


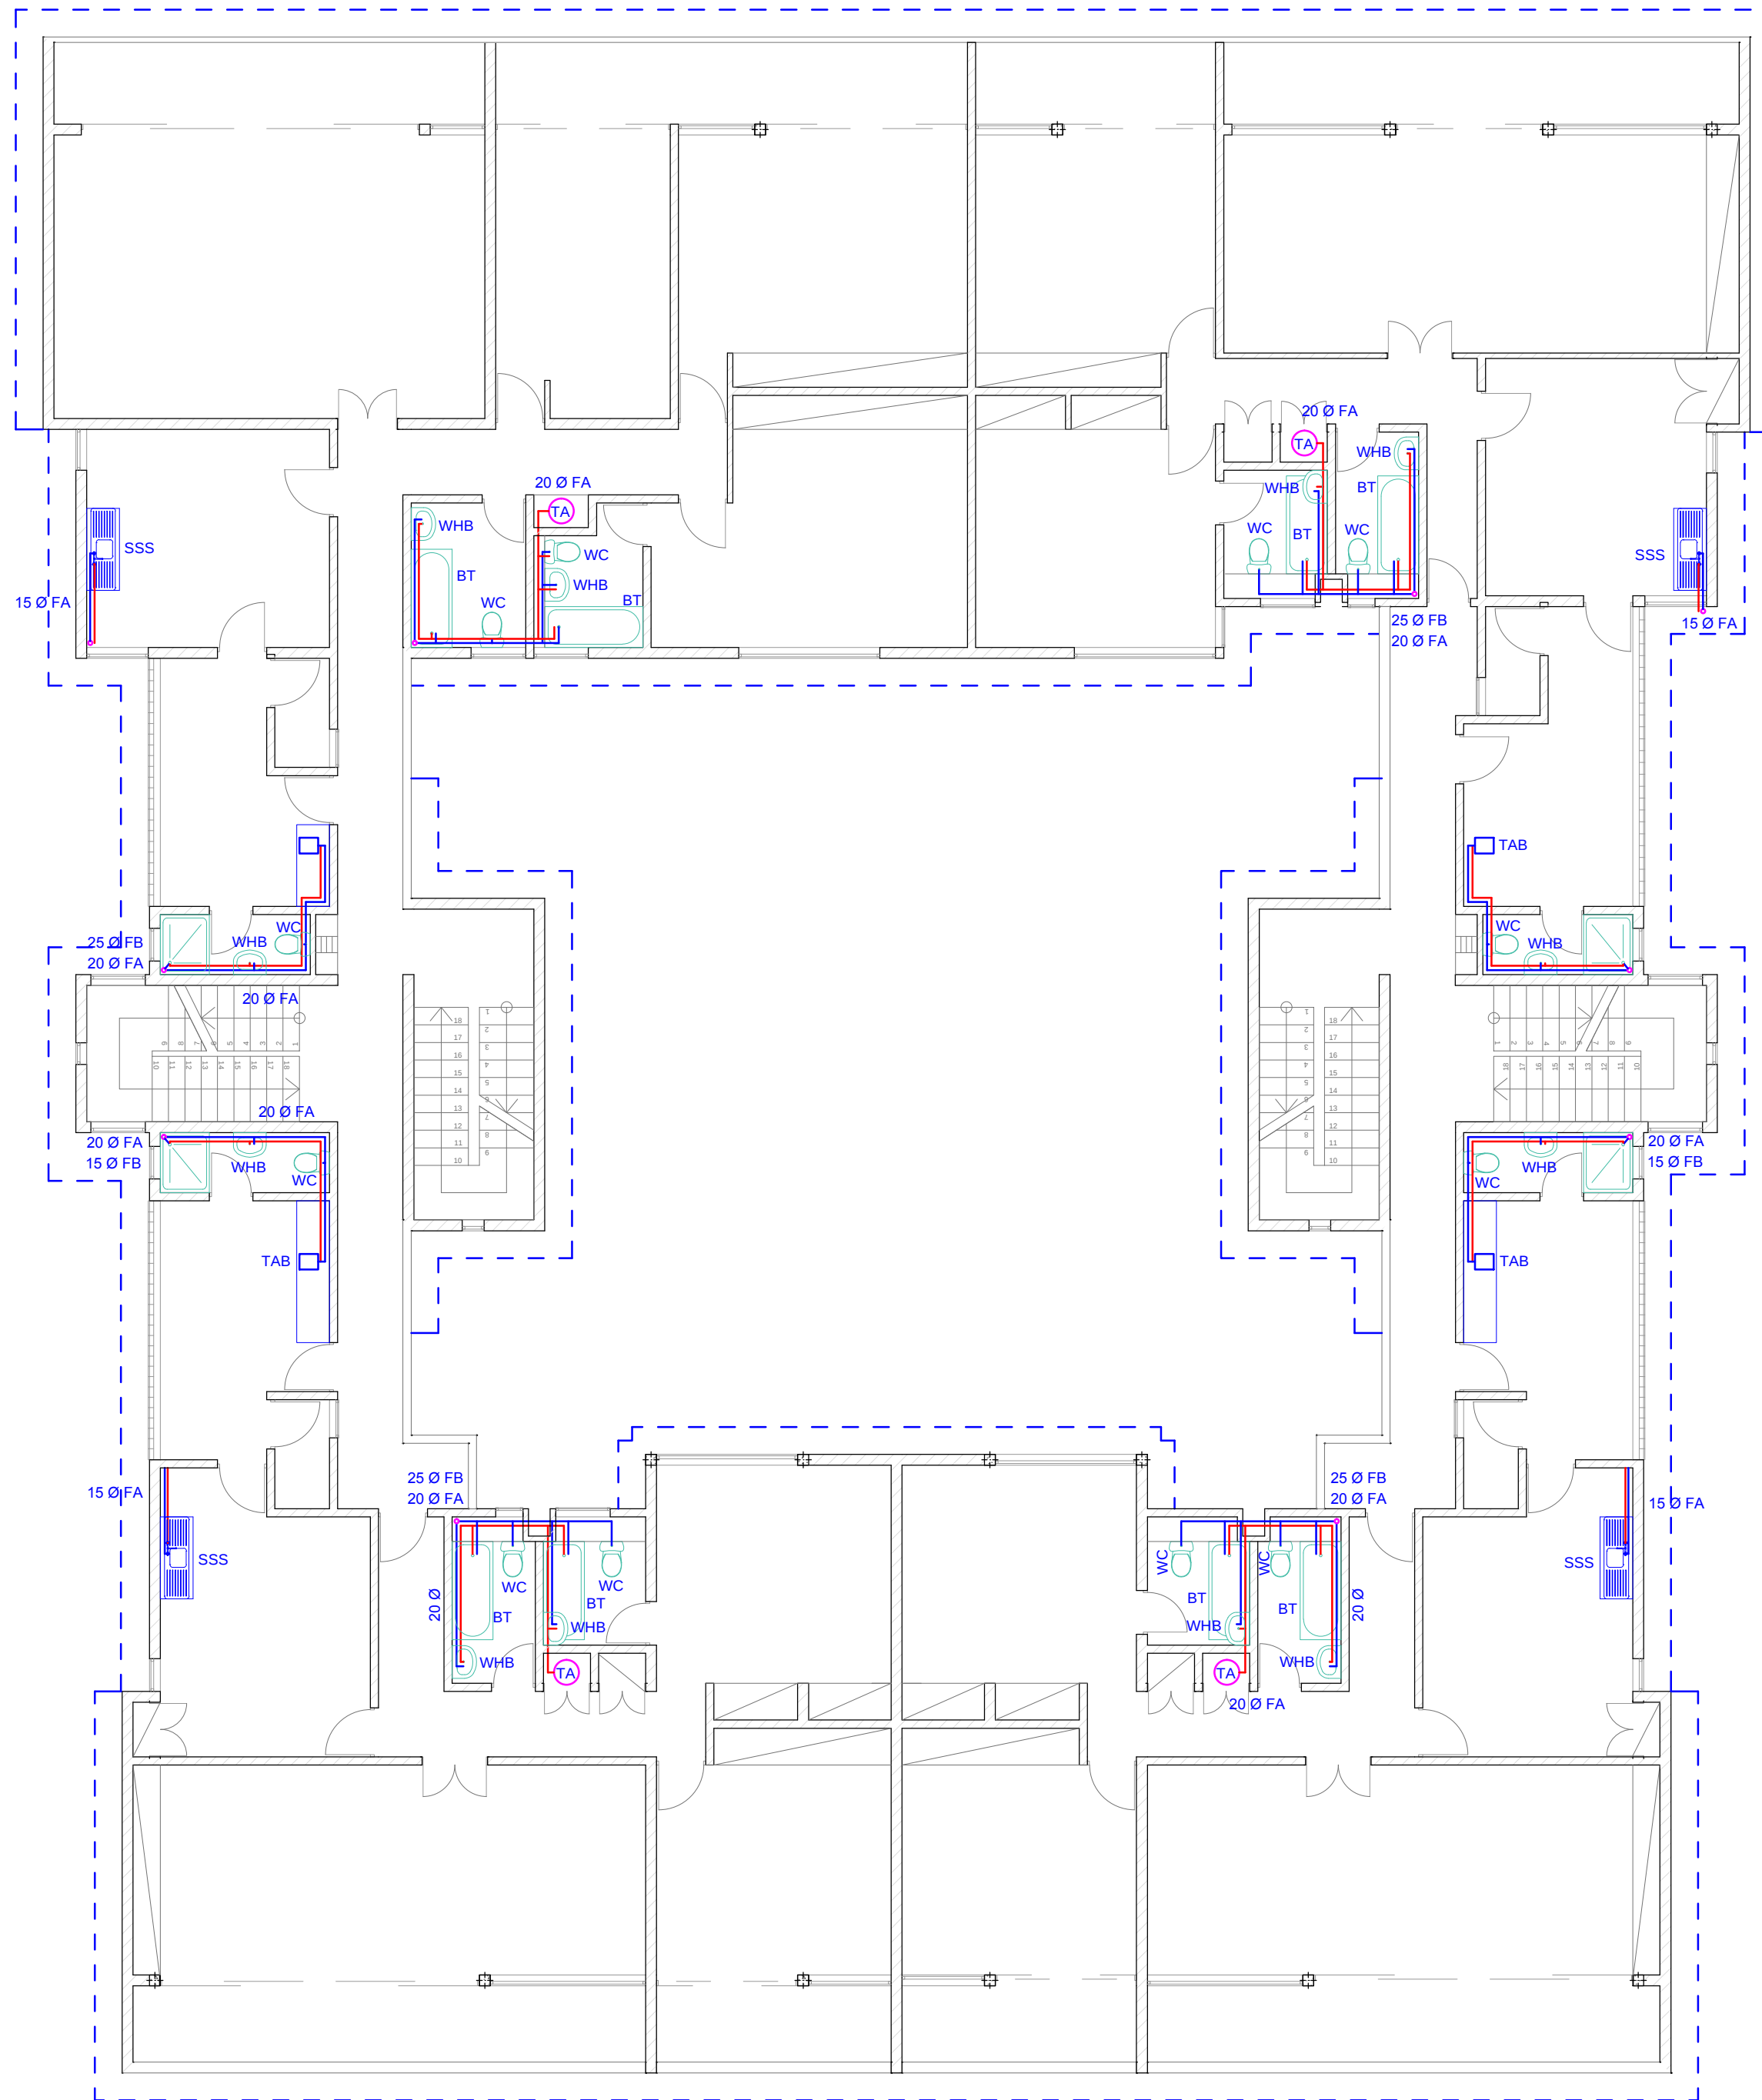

- SIMBOLOGIA**
- HOT WATER
 - COLD WATER
 - FINE EXTIMENTION PIPE
 - DISTRIBUITIN PIPE
 - WHB - TOWELS
 - WC - TOILET
 - SSS - DISHWASHER
 - BT/Sh - BATHTUB WITH SHOWER
 - FB - FEED PIPE
 - FA - COLD WATER DOWN PIPE

GENERAL NOTES

N°	REVISIN	DATE

Project: Reabilitation of Residential Compound

Client : UNDP

Locaton: MAPUTO

HYDRAULIC SPECIALTY

Object: WATER SUPPLY (SECOND FLOOR PLAN)	Drawing Number: HID 06
Date: SEPTEMBER, 2015	Paper Size A2
Scale: 1/100	