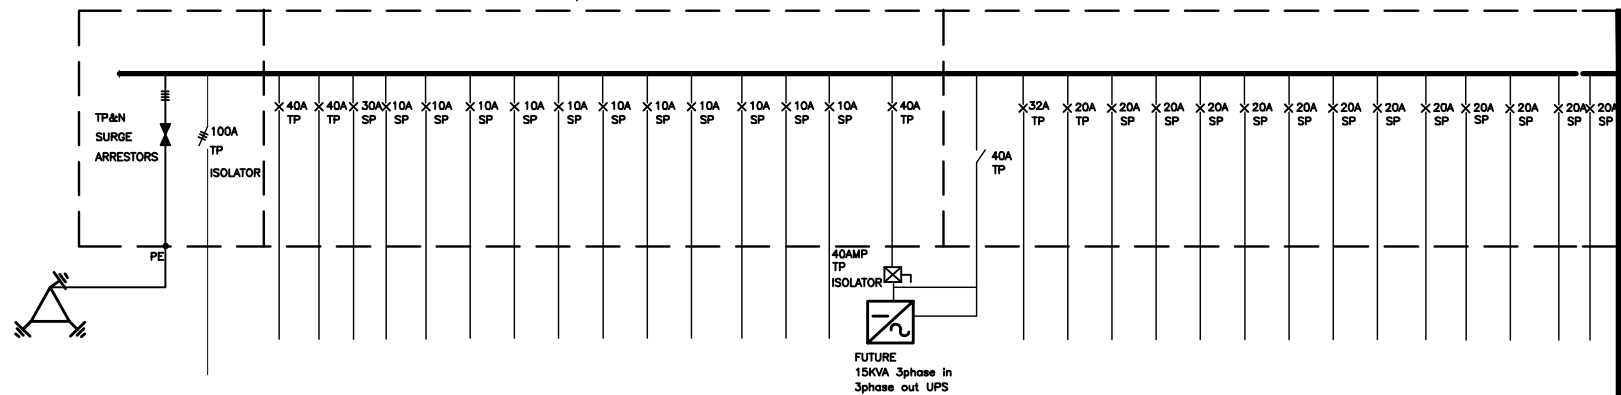
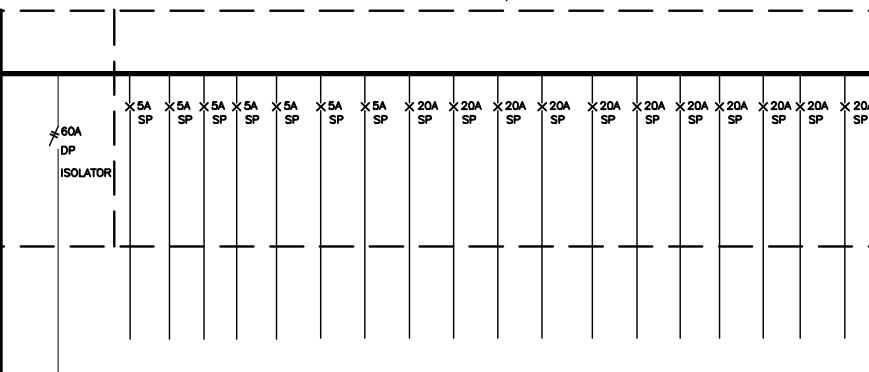



(REBUILD EXISTING FLUSH DB BY INSTALLING ALL NEW SWITCHGEAR & CIRCUITS
RETAIN EXISTING FLUSH TRAY, INCOMING CABLES)

[illegible]

(REBUILD EXISTING FLUSH DB BY INSTALLING ALL NEW SWITCHGEAR & CIRCUITS
RETAIN EXISTING FLUSH TRAY, INCOMING CABLES)

[illegible]

(REBUILD EXISTING FLUSH DB BY INSTALLING ALL NEW SWITCHGEAR & CIRCUITS
RETAIN EXISTING FLUSH TRAY)

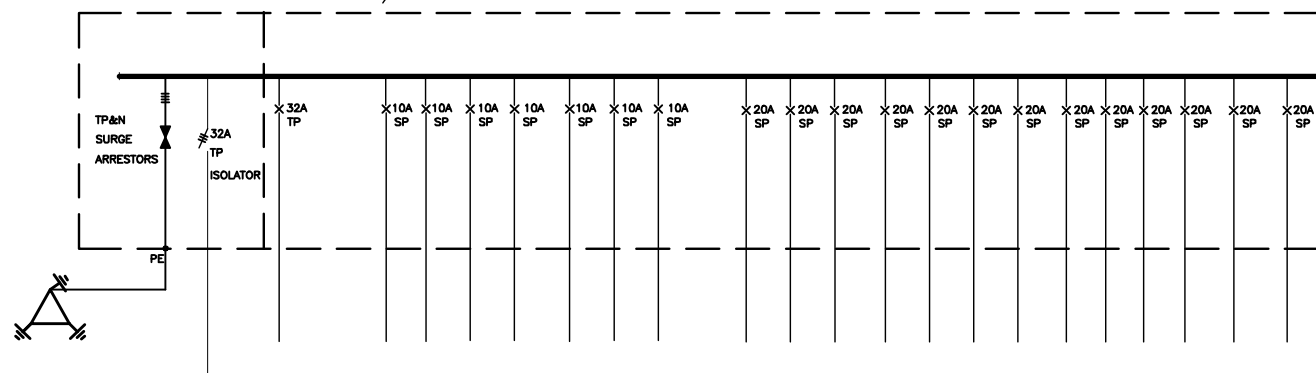
[illegible]

EXISTING DB - 4



EXISTING DB - 2

(REFURBISH DB, INSTALL NEW CIRCUIT BREAKERS
TO FEED NEW HVAC PLANT, REPLACE DB DOOR)

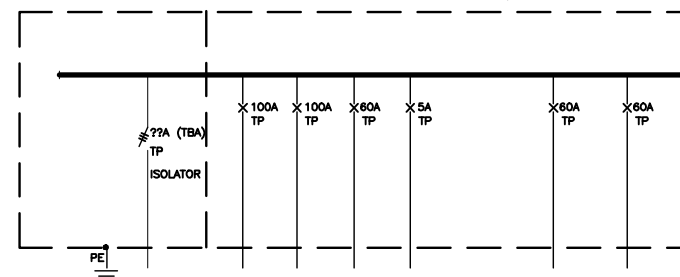[illegible]

EXISTING OUTDOOR DB

T	04/07/16	TENDER ISSUE
REVISION	DATE	DESCRIPTION

DRAWING STATUS
TENDER



16-4th Avenue Mabelreign, P.O.Box A1689 Avondale, Ha
T +263 4 310 023, F +263 4 305 920, E admin@gedzim.co



C.P.E
CHECK-POINT ENGINEER

Consulting • Design • Project Management

cpe@checkpointengineers.com
www.checkpointengineers.com
+263 77 224 8096

CLIENT

**MEDICINES CONTROL AUTHORITY OF ZIMBABWE
(MCAZ)**

PROJECT

REFURBISHMENT OF MCAZ MICROBIOLOGY LAB

DRAWING TITLE

ELECTRICAL
DISTRIBUTION BOARDS SCHEMATICS

DESIGNED	CPE	CHECKED	MM
----------	-----	---------	----

DRAWN	MM	CHECKED	
DATE	23/06/2016	SCALE	1:100

PROJECT N°	DRAWING N°	REVIS
0101	E103	T