




Top Slab Plan View

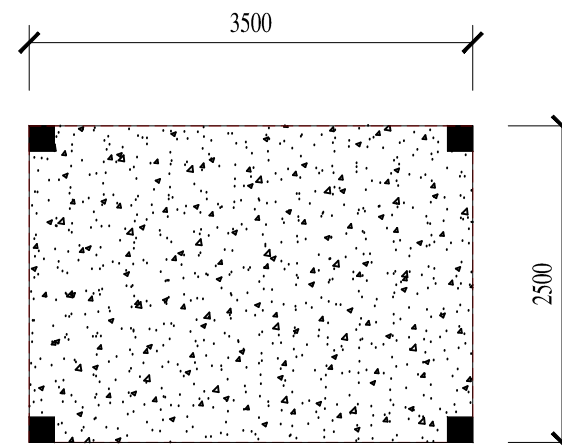

Mid Slab Plan View

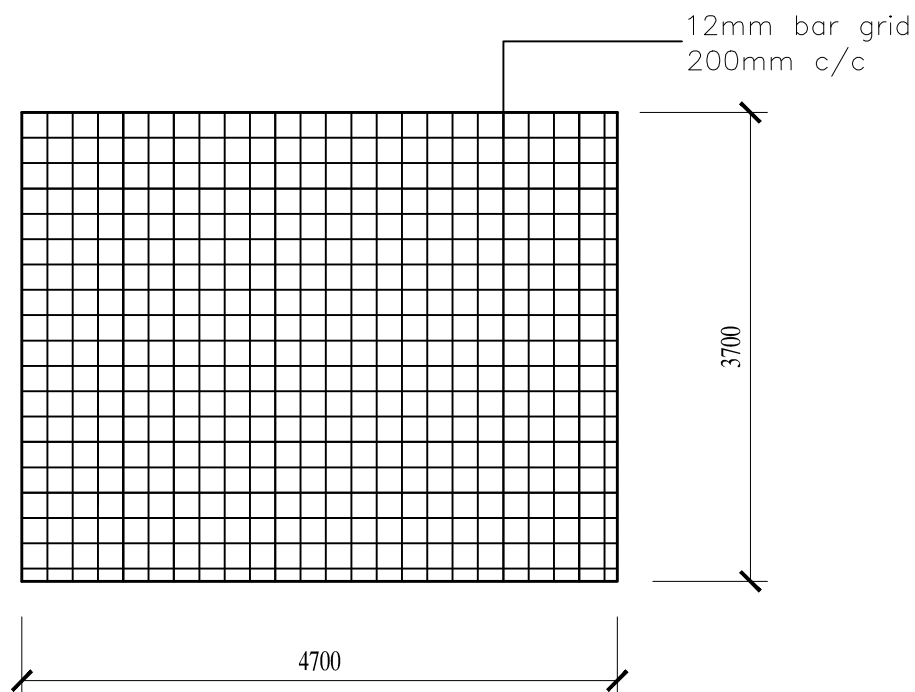

Top Slab Reinforcement Details

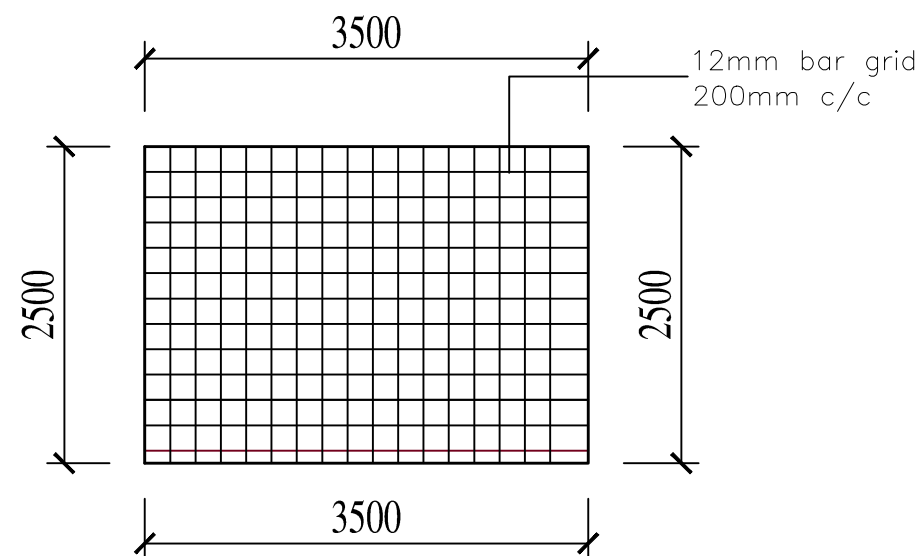

Mid Slab Reinforcement Details

NOTES

All dimensions are in millimeters and conform to B.S standards and mix ratio

Project:
GEF/UNDP/GoSL
Water Project
Construction of Bore Hole & Solar Powered Network

Location:

Western Area ,Kambia,Kono,
& Pujehun District.

Client:

Water Directorate
Ministry of water Resources

Reference	Lot	
	No	1, 2, 3, & 4

Drg. title:

**ELEVATED STORAGE
TANK WITH SOLAR**

suspended Slabs

Designed by Water Directorate

Drawn by Ing Sam Goba

Approved by Director
Water Resources

Scale 1: 50

Date October 2016

Drg No. GEF/UNDP/GoSL009