


New Substation shall be installed to
reduce overloads on the initial
substation

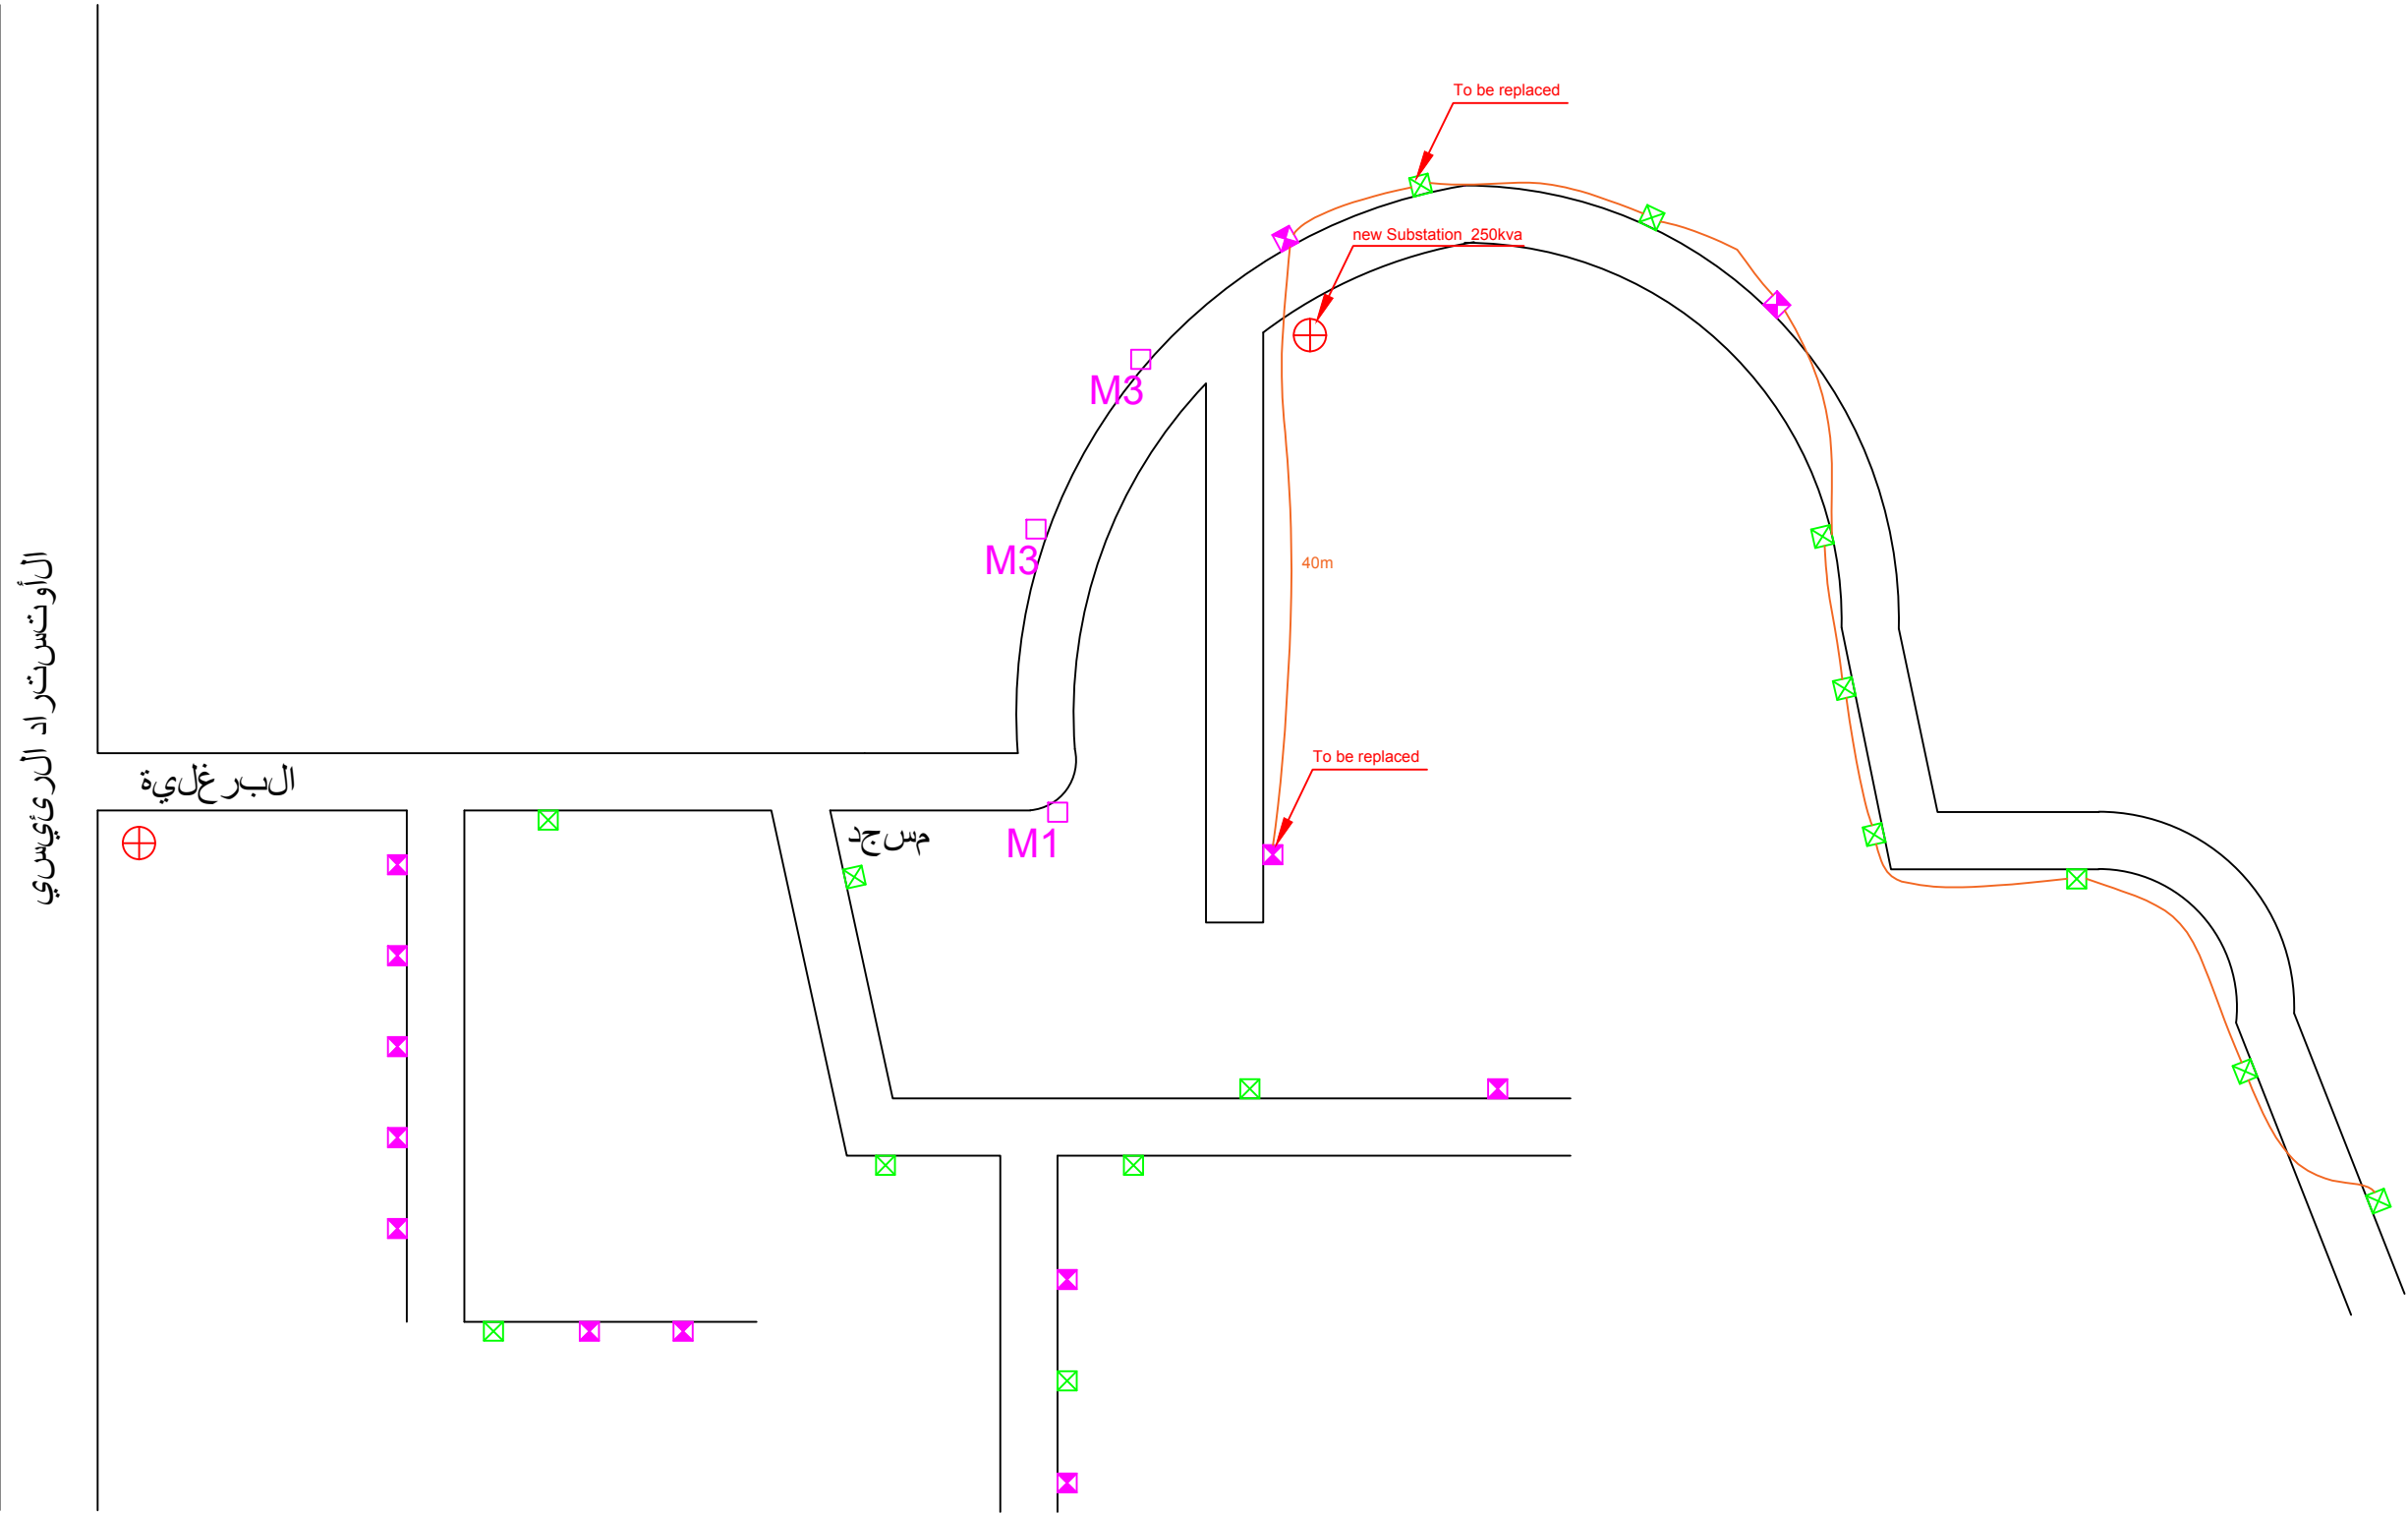

LEGEND AND SYMBOLS

- ELECTRICAL SUBSTATION
- A1- ELECTRICAL METAL POLE
- A2- ELECTRICAL METAL POLE
- WOOD POLE
- TELEPHONE POLE
- BUNDLE CABLE:3*150+70+16mm2
- BUNDLE CABLE:3*70+54.6+16mm2

NOTES

Rev #	DESCRIPTION	DATE	CHECK

Project
مشروع تاهيل الشبكات الكهربائية / بلدة البرغلية الشمالية
CLIENT
UNDP
(Improving Living Conditions in Palestinian
Gatherings Host Communities)

Drawing Number and Title
SITE ELECTRICAL LAYOUT

Revision Number00			
TRADE ELECTRICAL		DRAWN BY ENG. A. DARHIL	
SITE	Bldg	Floor	Unit
البرغلية الشمالية	-	-	-
SCALE	DATE	SHEET NO. EL-05	
	JUNE-2016		