

محطة العزينة








بناية فوهان

محطة نورا



محطة نورا
محطة الجامع

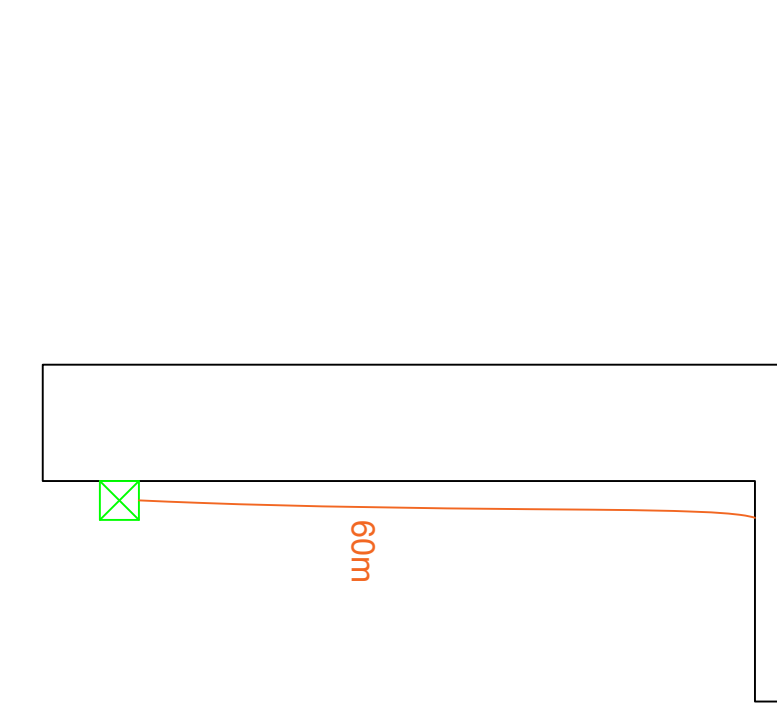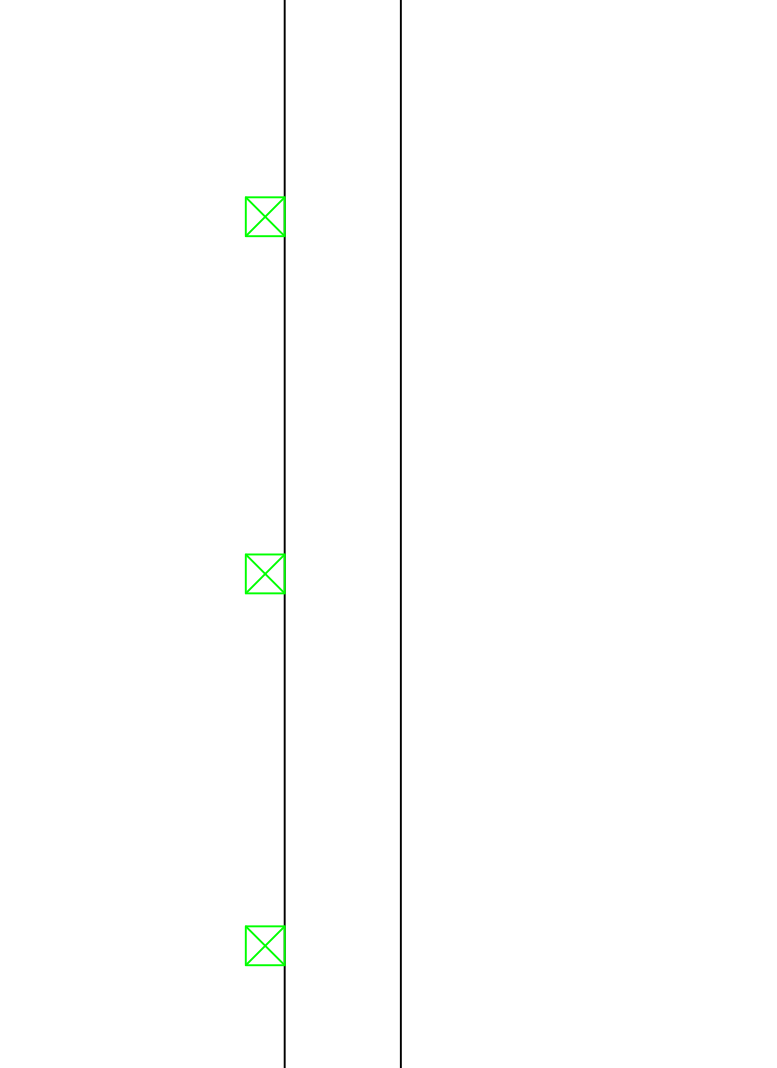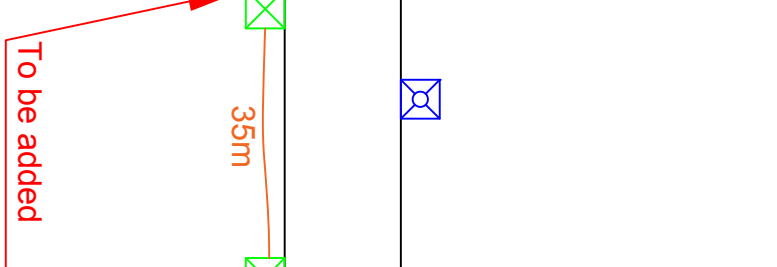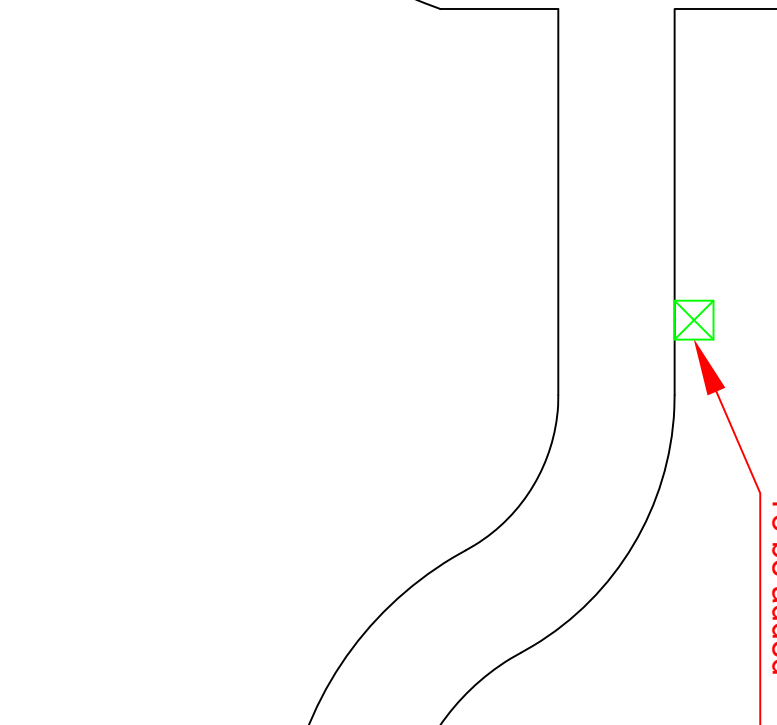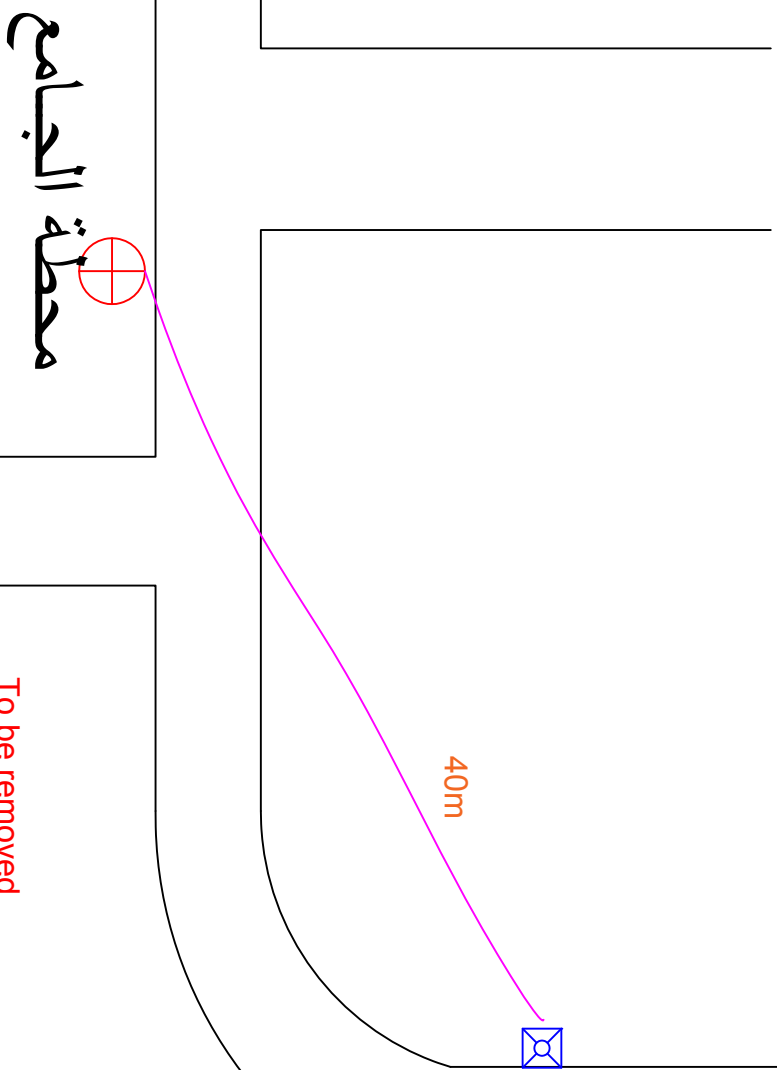

Good substation and transmission lines;
only external lighting to be added

LEGEND AND SYMBOLS

- ELECTRICAL SUBSTATION
- A1- ELECTRICAL METAL POLE
- A2- ELECTRICAL METAL POLE
- WOOD POLE
- TELEPHONE POLE
- BUNDLE CABLE: 3*150+70+16mm2
- BUNDLE CABLE: 3*70+54+6+16mm2

NOTES

Rev	#	DESCRIPTION	DATE	CHECK

Project: مشروع تحسين البنية التحتية / منطقة 3
Client: UNDP
(Improving Living Conditions in Palestinian Gatherings Host Communities)

SITE ELECTRICAL LAYOUT

Revision Number: 00

Drawn by: ENGR. A. DAMRI

Checked by: ENGR. A. DAMRI

Scale: 1:100

Sheet No: EL-06

Date: JUNE 2016