


طريق الوسطة الفرقة - البلد

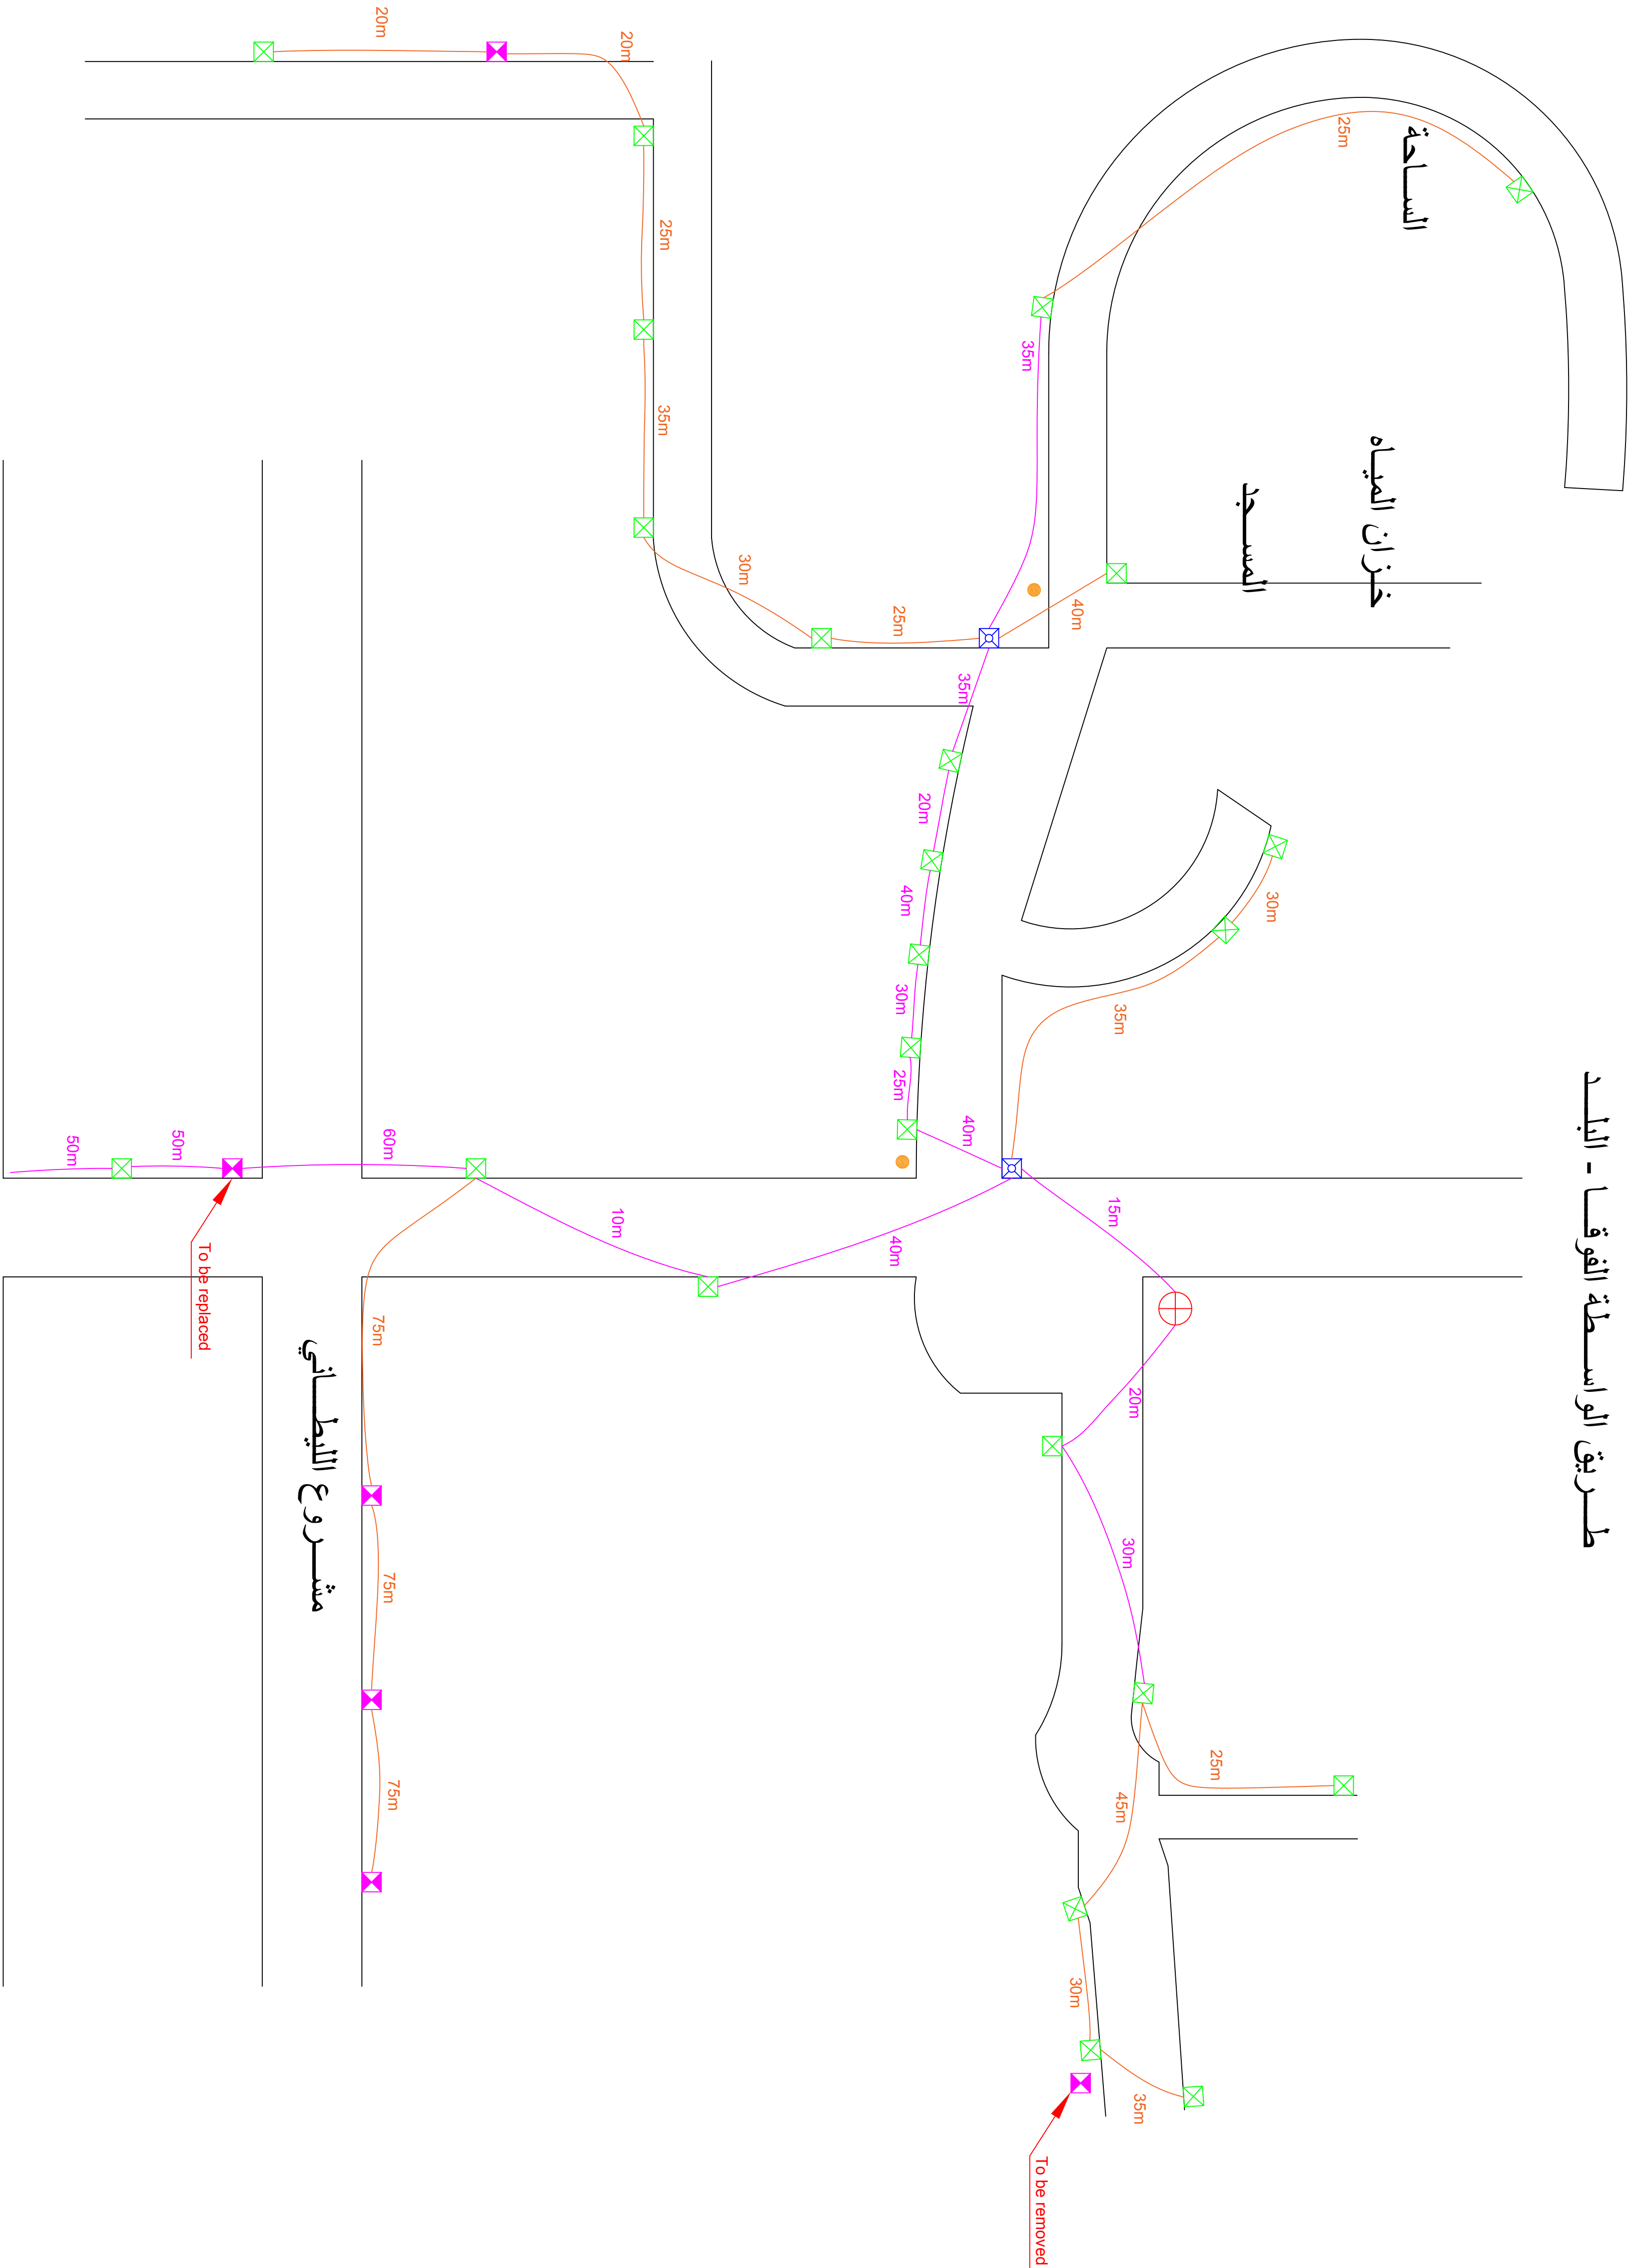

LEGEND AND SYMBOLS

- ELECTRICAL SUBSTATION
- A1- ELECTRICAL METAL POLE
- A2- ELECTRICAL METAL POLE
- WOOD POLE
- TELEPHONE POLE
- BUNDLE CABLE: 3*150+70+16mm2
- BUNDLE CABLE: 3*70+54+6+16mm2

NOTES

Row #	DESCRIPTION	DATE	CHECK

Project: مشروع تحسين ظروف التجمعات السكانية
Client: UNDP
(Improving Living Conditions in Palestinian Gatherings Host Communities)

SITE ELECTRICAL LAYOUT

Revision Number	00
Drawn by	ENG. A. DAKHLI
Checked by	
Scale	
Date	JUNE 2016