


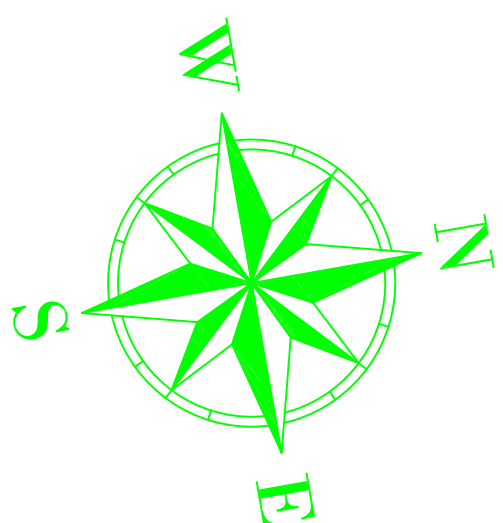

KEY PLAN

THIS DRAWING IS A COPYRIGHT. DO NOT SCALE FROM THE DRAWING.
THE CONTRACTOR AND HIS SUB-CONTRACTORS ARE TO VERIFY ALL DIMENSIONS ON SITE BEFORE MAKING SHOP DRAWINGS OR COMMENCING MANUFACTURE.

United Nation Development Programme
UNDP Lebanon
Social and Local Development Programme
P.O.Box: 11-3216 Beirut, Lebanon
Tel: 961 1 962491

PROGRAMME: Lebanese Host Communities
Support Programme
Support to Integrated Service
Provision at the Local Level

PROJECT NAME:

RMEILEH PUBLIC GARDEN

NOTES:

0	---	---	GENERAL REVISION	---
REV	BY	Date	Description	Appr.
PROJECT NBR. ---				
PROJECT PHASE TENDER				
DISCIPLINE CIVIL ENGINEERING				
SECTOR				
BUILDING	---			
DESIGNED	---			
DRAWN	---			
CHECKED	---			
APPROVED	---			
DATE	07 JANUARY 2017			
SCALE	1:100cm			
SHEET SIZE	A1			



RMEILEH PUBLIC GARDEN


OVERALL LAYOUT

Sheet 1 OF 1

RP-TD-AR-01-REV.0

Project Number	Phase	Type	Drawing Number	Revision
----------------	-------	------	----------------	----------

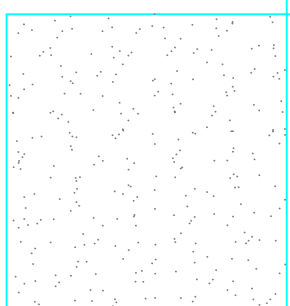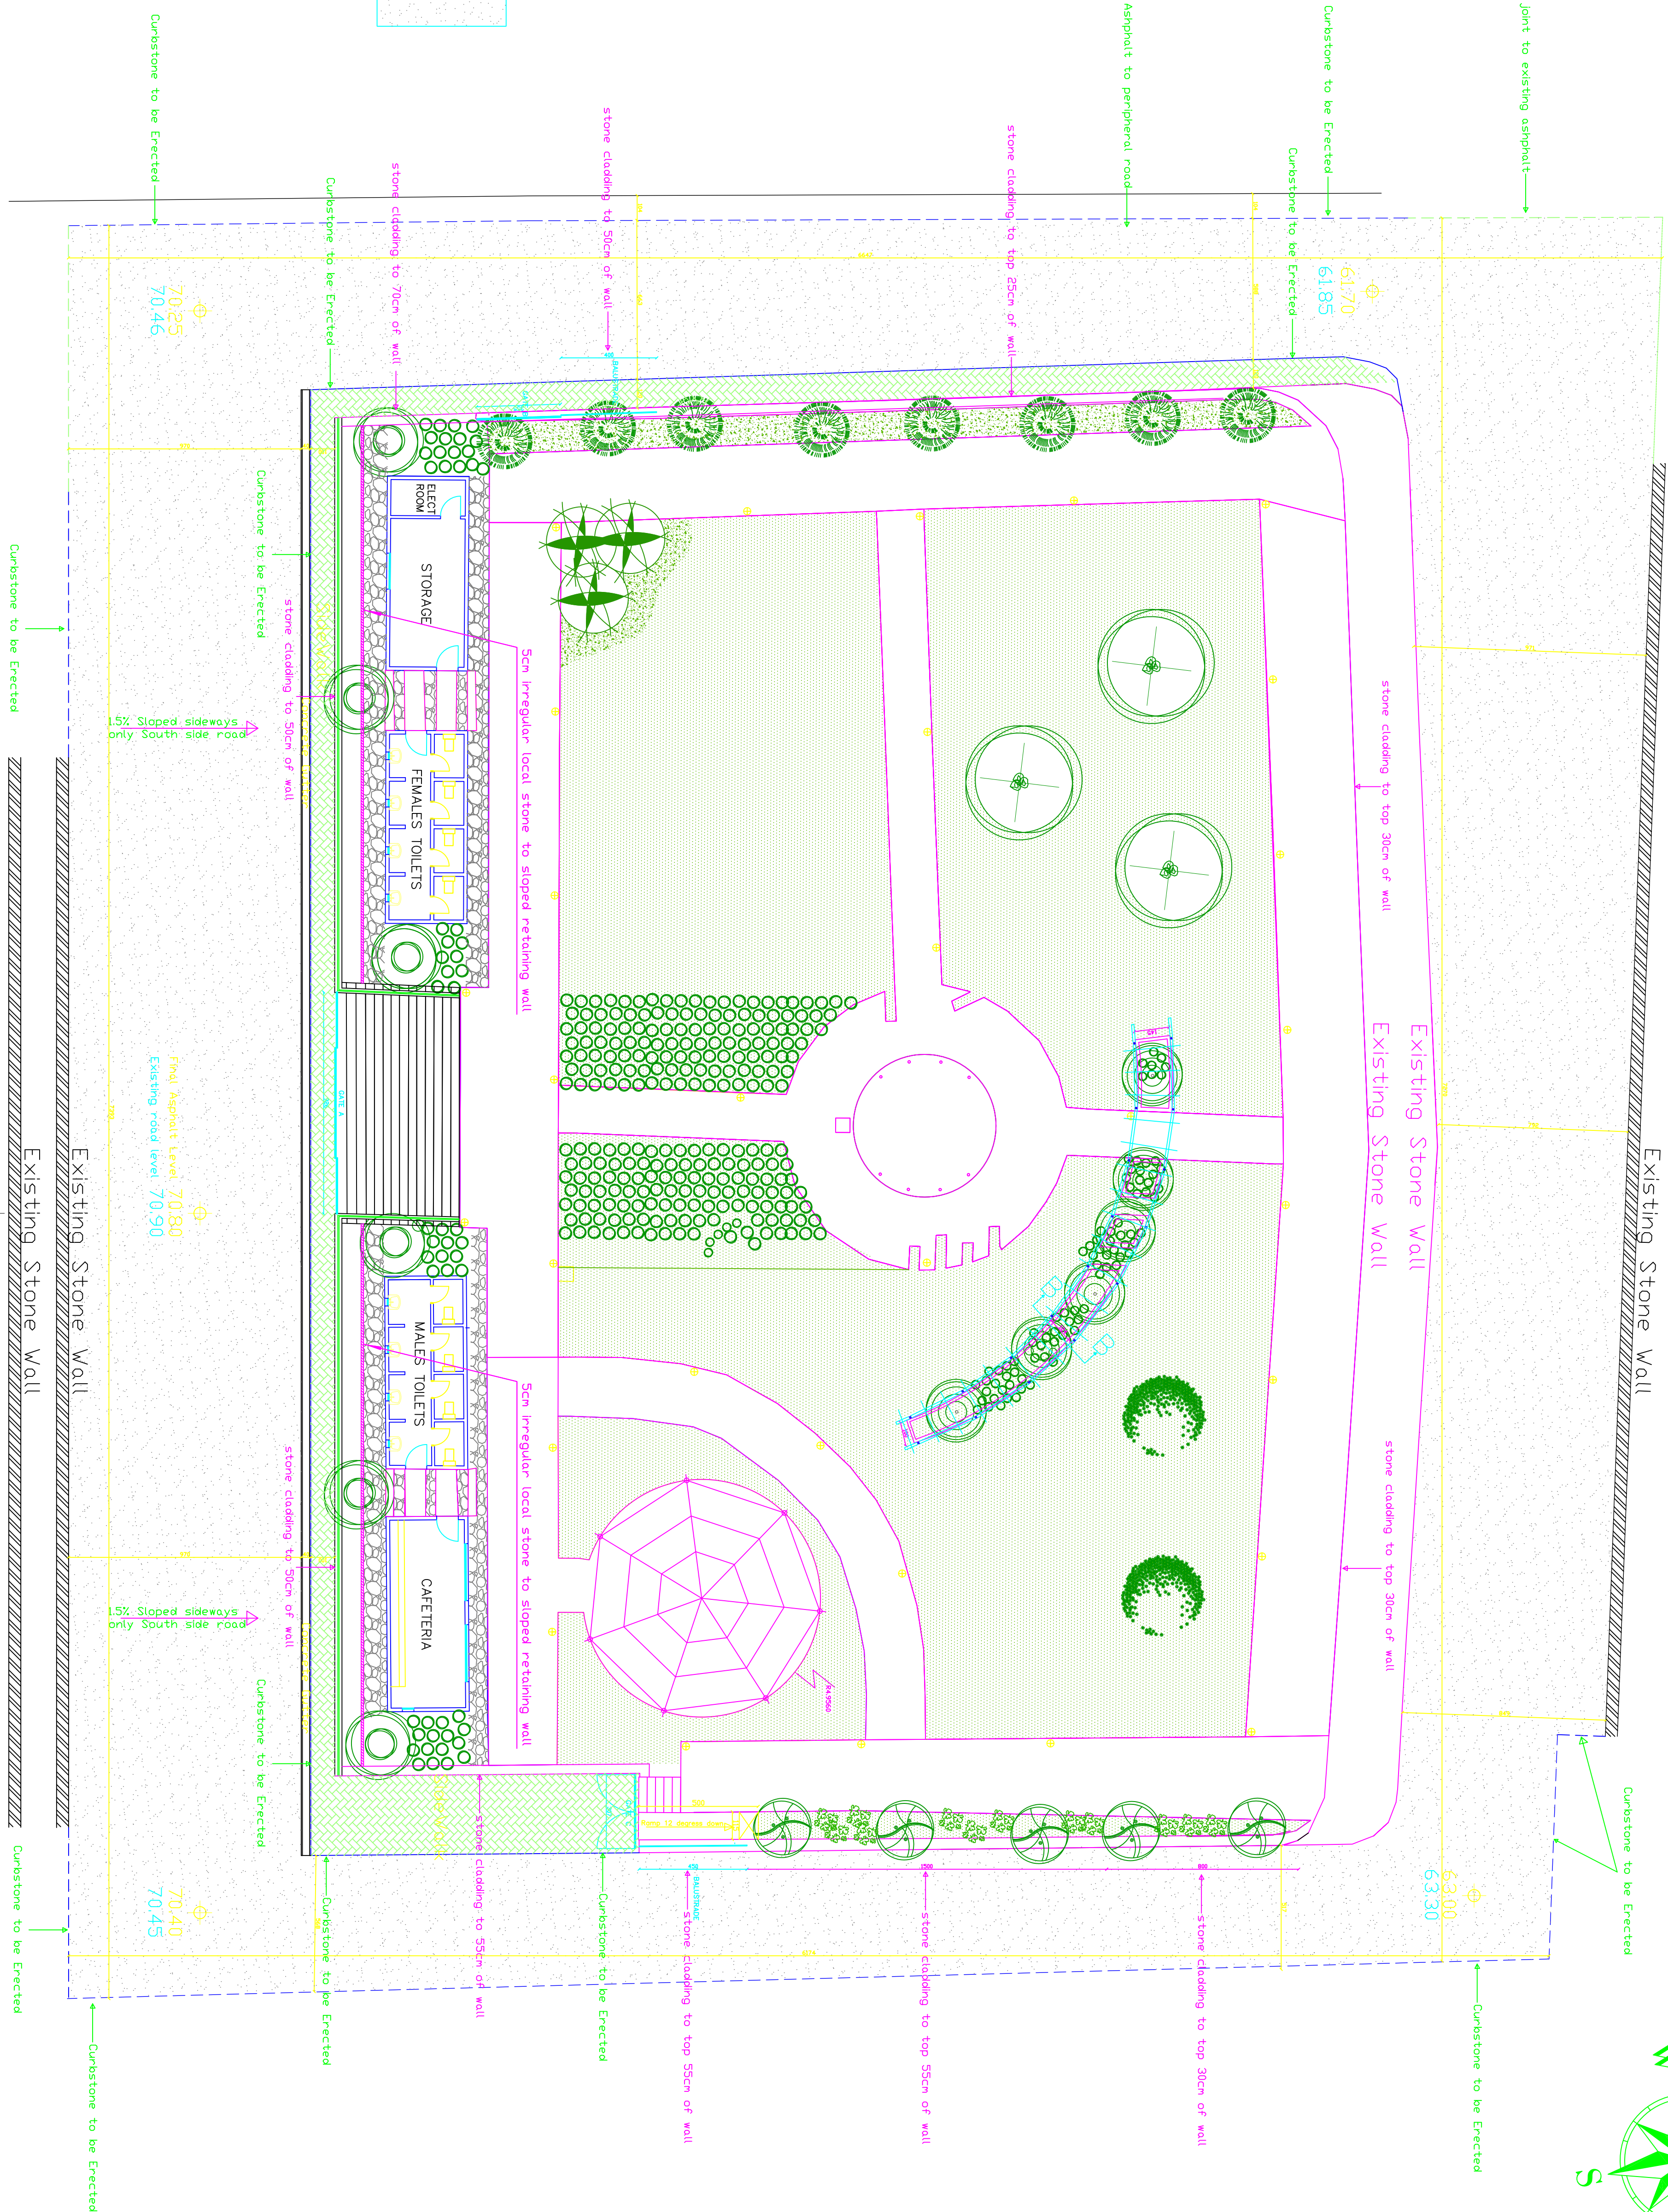

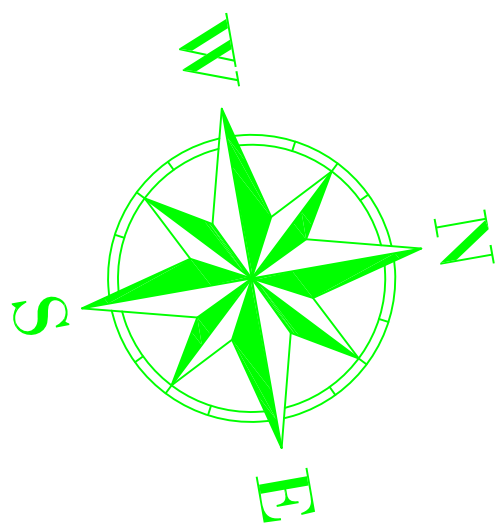

KEY PLAN

THIS DRAWING IS A COPYRIGHT. DO NOT SCALE FROM THE DRAWING. THE CONTRACTOR AND HIS SUB-CONTRACTORS ARE TO VERIFY ALL DIMENSIONS ON SITE BEFORE MAKING SHOP DRAWINGS OR COMMENCING MANUFACTURE.



United Nation Development Programme
UNDP Lebanon
Social and Local Development Programme
P.O.Box: 11-3216 Beirut, Lebanon
Tel: 961 1 962491



UNDP
United Nations Development Programme
P.O.Box: 11-3216 Beirut, Lebanon
Tel: 961 1 962491

PROGRAMME: Lebanese Host Communities Support Programme
Support to Integrated Service Provision at the Local Level

PROJECT NAME:

RMEILEH PUBLIC GARDEN

NOTES:





0	---	---	GENERAL REVISION	---
REV	BY	Date	Description	Appr.
PROJECT NBR. ---				
PROJECT PHASE TENDER				
DISCIPLINE CIVIL ENGINEERING				
SECTOR				
BUILDING				
DESIGNED ---				
DRAWN ---				
CHECKED ---				
APPROVED				
DATE 07 JANUARY 2017				
SCALE 1:100cm				
SHEET SIZE A1				
Title				


RMEILEH PUBLIC GARDEN
PLANTATION DETAILS

Sheet 1 OF 1

RP-TD-AR-02-REV.0

Project Number	Phase	Type	Drawing Number	Revision
----------------	-------	------	----------------	----------

    	Cocos Plumosa -6-
	Morus Platanifolia -3-
	Sapindus India -2-
	Ficus Australis -6-
	Washingtonia Robusta -6-
	Archontophoenix Alexandrea -3-
	Robinia Pseudoacacia -8-
	Pittosporum Tobira -150-
	Strelitzia Reginae-80-
	Hibiscus -100-
	Chamaerops Humilis -75-
	Central Zone,40 of each 5 kinds
	Natural grass St. Augustine
	Artificial Grass for Kids Games

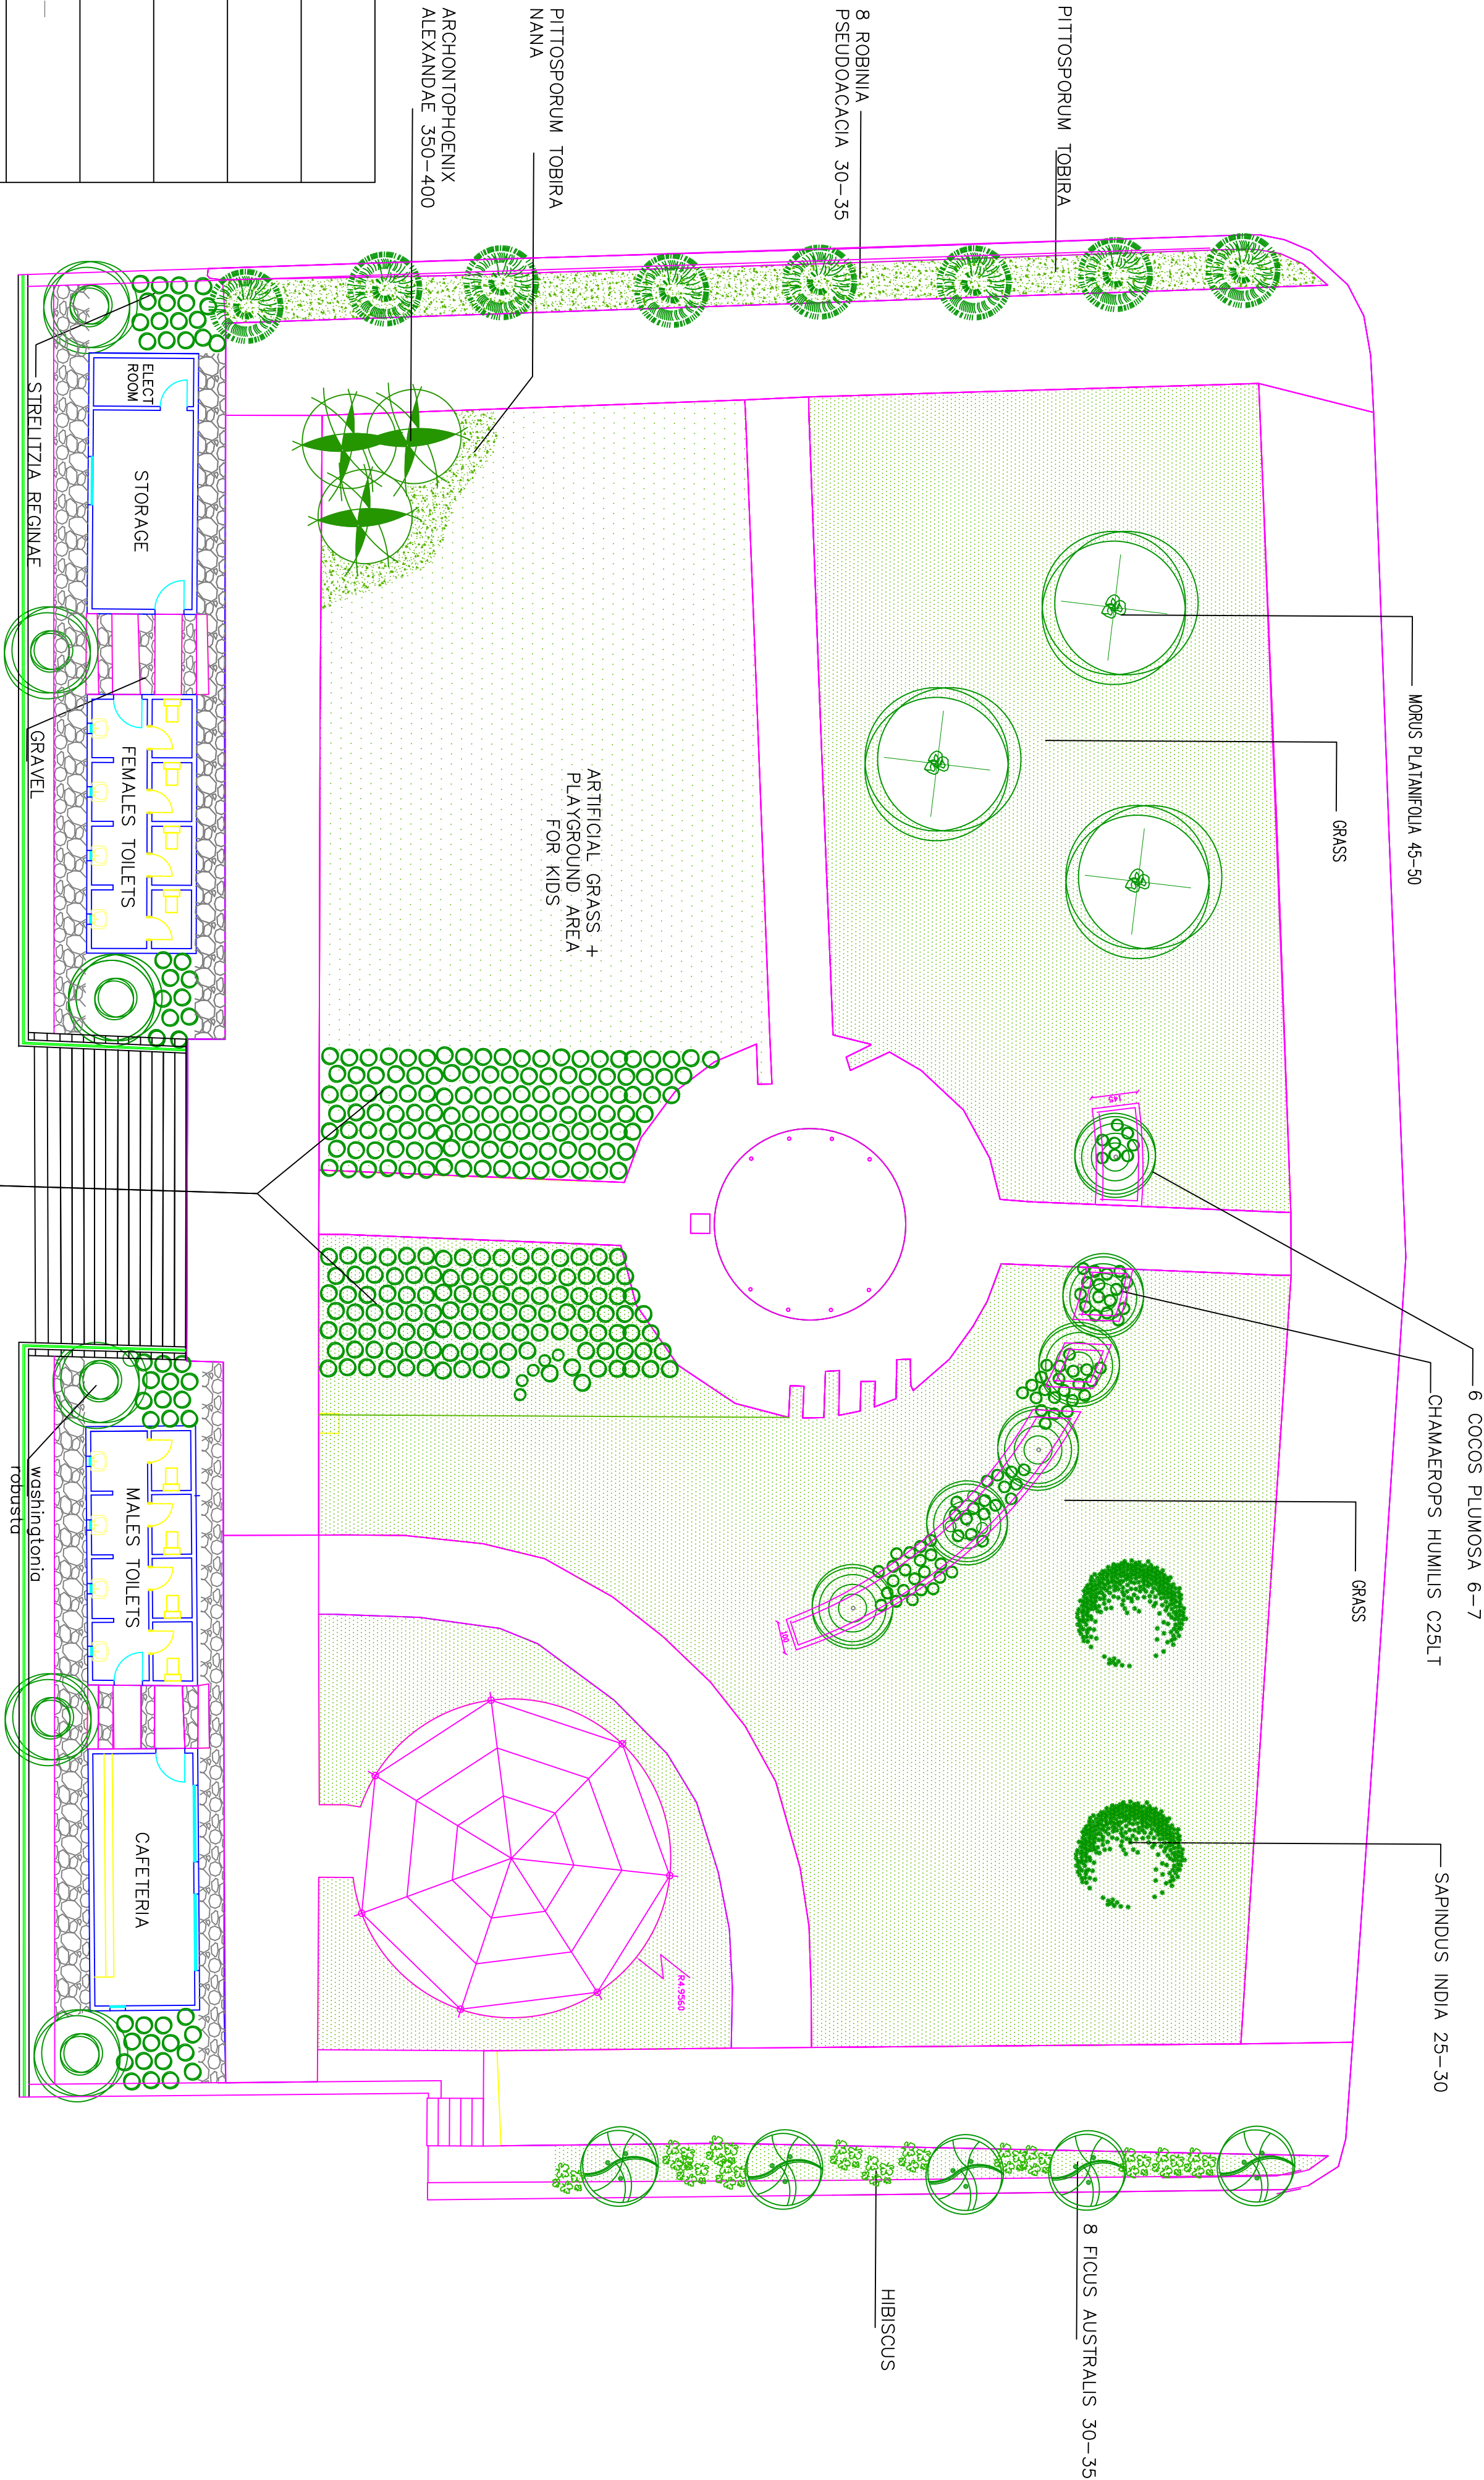

KEY PLAN

THIS DRAWING IS A COPYRIGHT. DO NOT SCALE FROM THE DRAWING. THE CONTRACTOR AND HIS SUB-CONTRACTORS ARE TO VERIFY ALL DIMENSIONS ON SITE BEFORE MAKING SHOP DRAWINGS OR COMMENCING MANUFACTURE.



 United Nation Development Programme
UNDP Lebanon
Social and Local Development Programme
P.O.Box: 11-3216 Beirut, Lebanon
Tel: 961 1 962491

PROGRAMME: Lebanese Host Communities Support Programme
Support to Integrated Service Provision at the Local Level

PROJECT NAME:

RMEILEH PUBLIC GARDEN

NOTES:

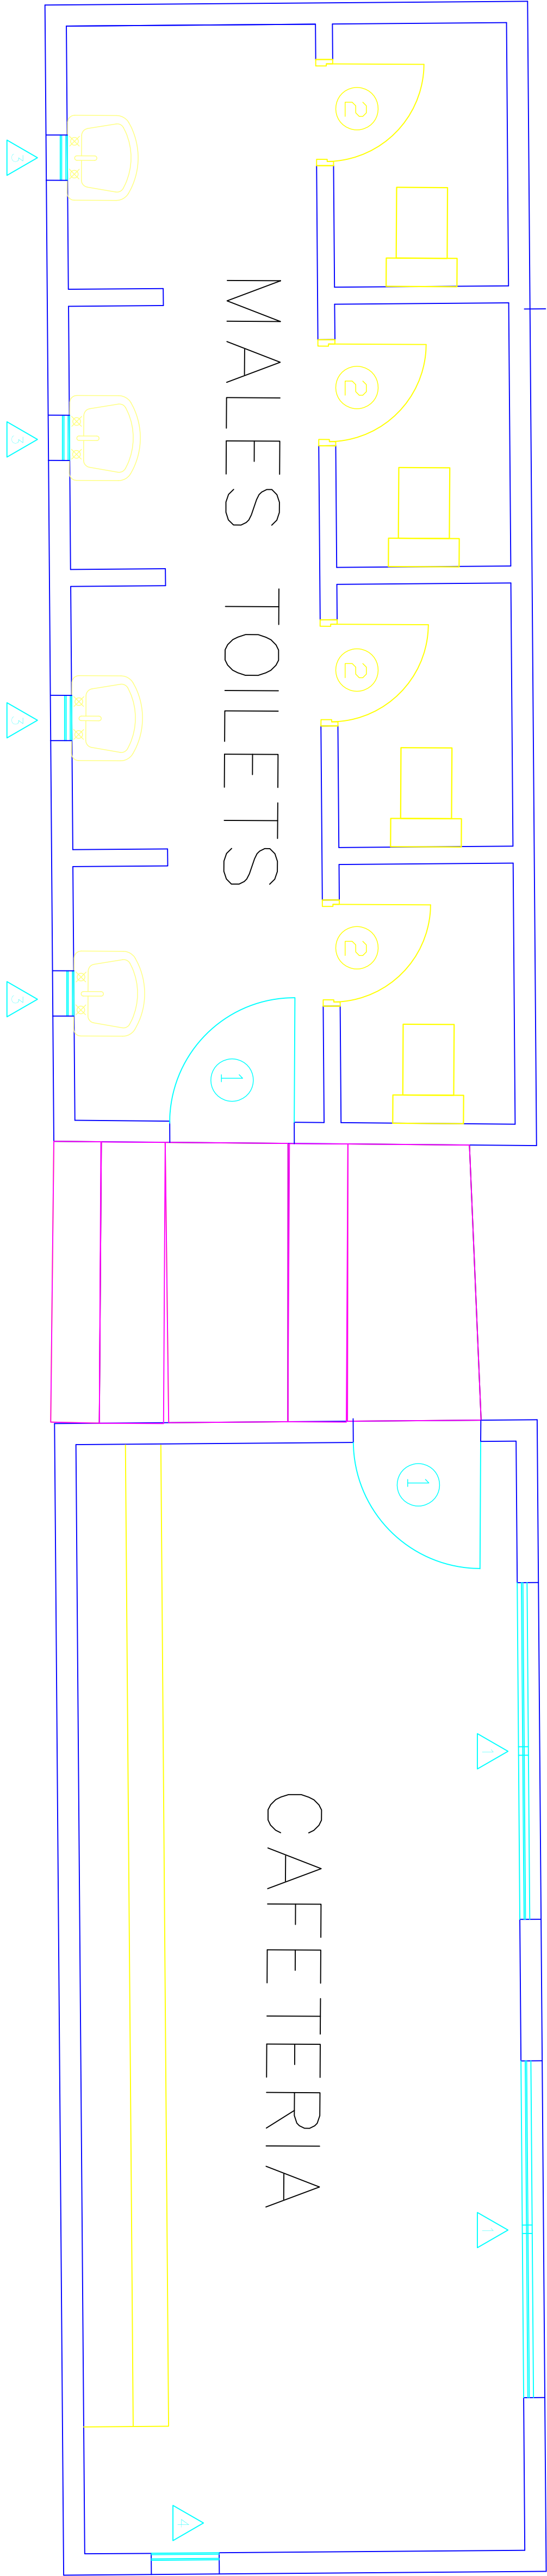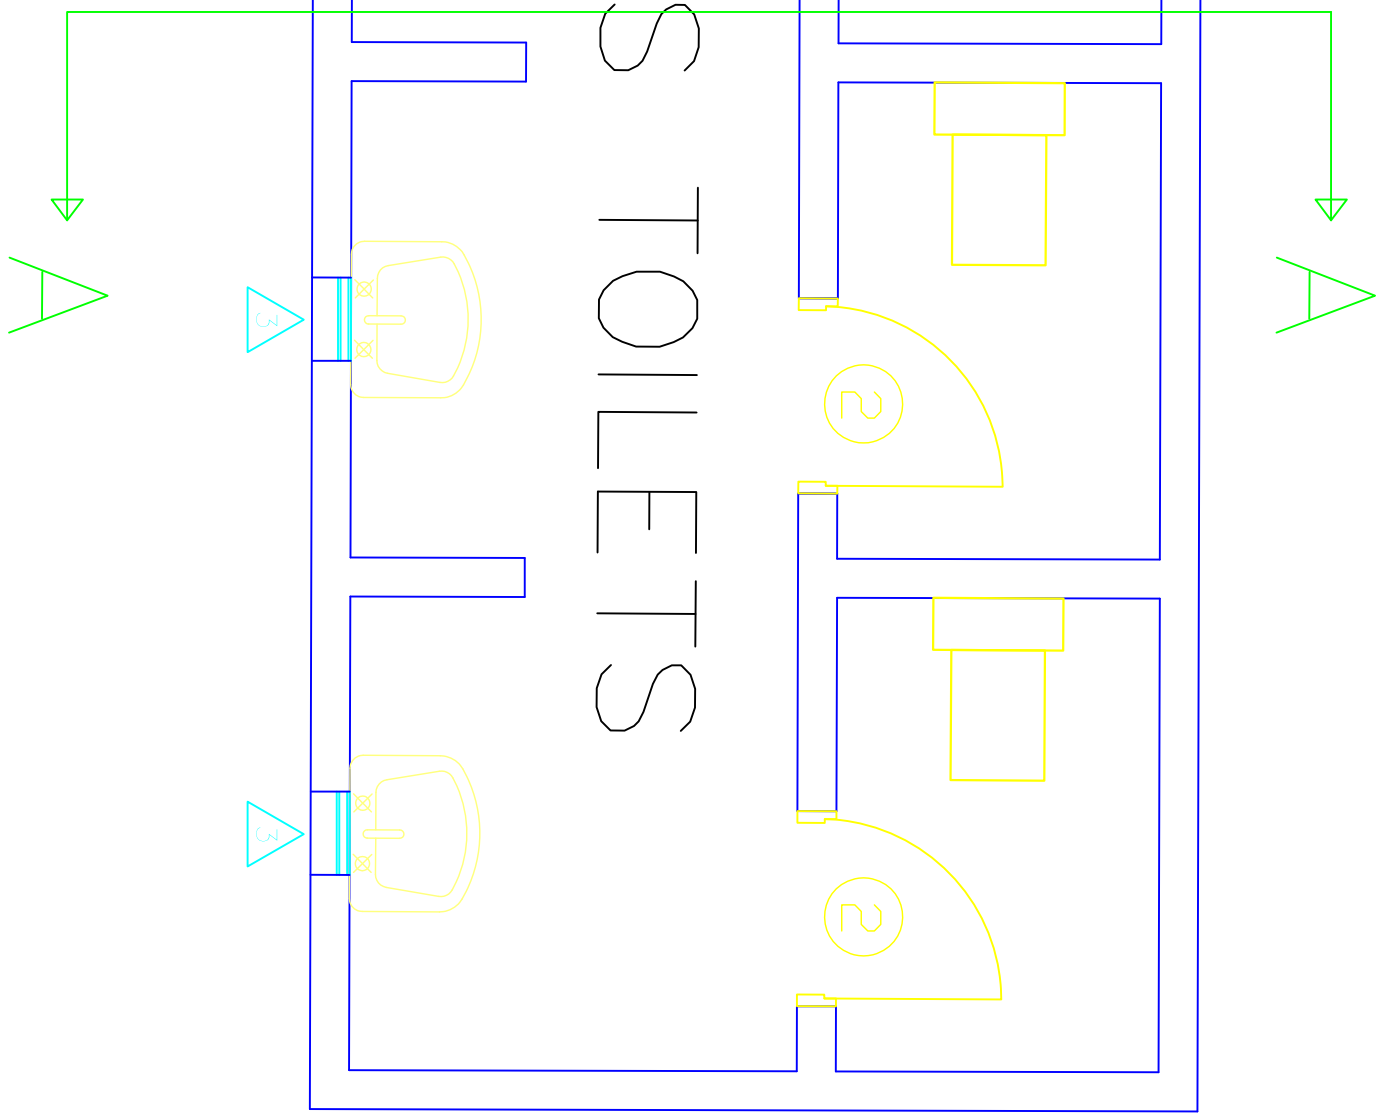

0	---	---	GENERAL REVISION	---
REV	BY	Date	Description	Appr.
PROJECT NBR. ---				
PROJECT PHASE TENDER				
DISCIPLINE CIVIL ENGINEERING				
SECTOR				
BUILDING				
DESIGNED ---				
DRAWN ---				
CHECKED ---				
APPROVED				
DATE 07 JANUARY 2017				
SCALE 1:20cm				
SHEET SIZE A1				
Title				

RMEILEH PUBLIC GARDEN

ROOMS PLANS AND LAYOUT

Sheet 1 OF 1

RP-TD-AR-03-REV.0

Project Number	Phase	Type	Drawing Number	Revision
----------------	-------	------	----------------	----------

KEY PLAN

THIS DRAWING IS A COPYRIGHT. DO NOT SCALE FROM THE DRAWING. THE CONTRACTOR AND HIS SUB-CONTRACTORS ARE TO VERIFY ALL DIMENSIONS ON SITE BEFORE MAKING SHOP DRAWINGS OR COMMENCING MANUFACTURE.



United Nation Development Programme
UNDP Lebanon
Social and Local Development Programme
P.O.Box: 11-3216 Beirut, Lebanon
Tel: 961 1 962491



Lebanese Host Communities
Support Programme
Support to Integrated Service
Provision at the Local Level

PROJECT NAME:

RMEILEH PUBLIC GARDEN

NOTES:

0	---	GENERAL REVISION	---
REV	BY	Date	Description
PROJECT NBR. ---			
PROJECT PHASE TENDER			
DISCIPLINE CIVIL ENGINEERING			
SECTOR			
BUILDING			
DESIGNED			
DRAWN			
CHECKED			
APPROVED			
DATE 07 JANUARY 2017			
SCALE			
SHEET SIZE A1			
Title			


RMEILEH PUBLIC GARDEN
ARCHITECTURAL DETAILS
DOORS, WINDOWS, GATES

Sheet 1 OF 1


RP-TD-AR-04-REV.0

Project Number	Phase	Type	Drawing Number	Revision
----------------	-------	------	----------------	----------

Number	Symbol	Material	Description
1		50x7mm steel plate	For railing, this plate is used to connect the railing to the wall.
2		50x7mm steel plate	For railing, this plate is used to connect the railing to the wall.
3		50x7mm steel plate	For railing, this plate is used to connect the railing to the wall.
4		50x7mm steel plate	For railing, this plate is used to connect the railing to the wall.
5		50x7mm steel plate	For railing, this plate is used to connect the railing to the wall.
6		50x7mm steel plate	For railing, this plate is used to connect the railing to the wall.

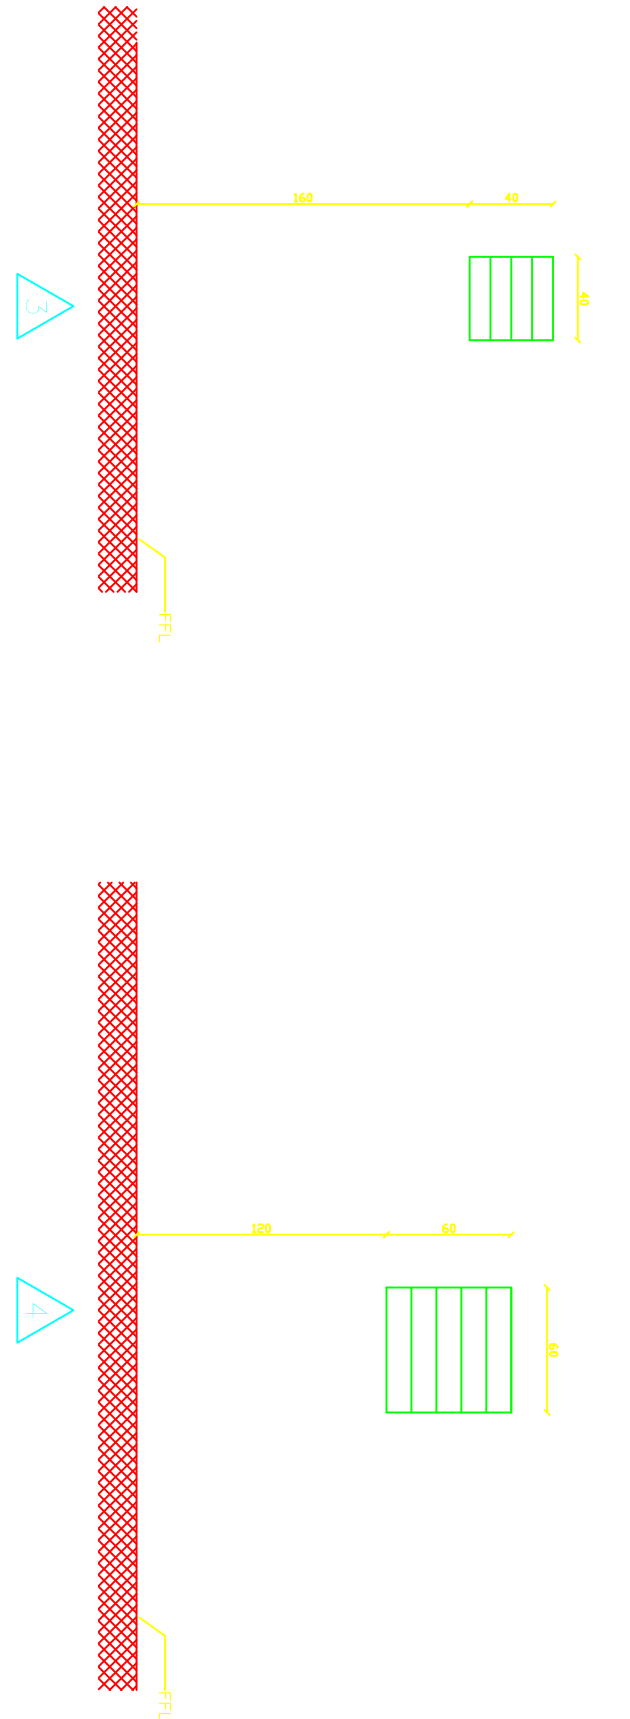


ALUMINUM SCHEDULE
Scale 1:25 cm

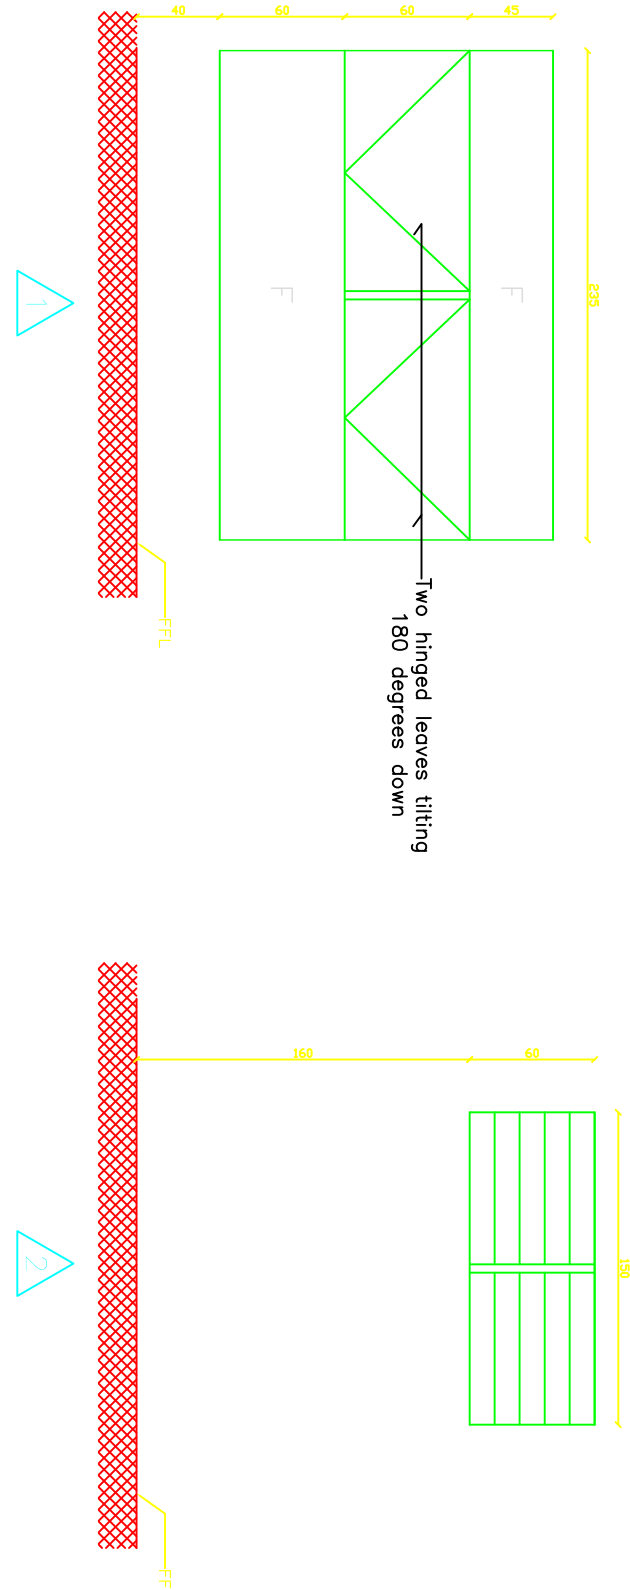


STEEL BALUSTRADE
Scale 1:10 cm

WOODEN CAP
Scale 1:2.5 cm

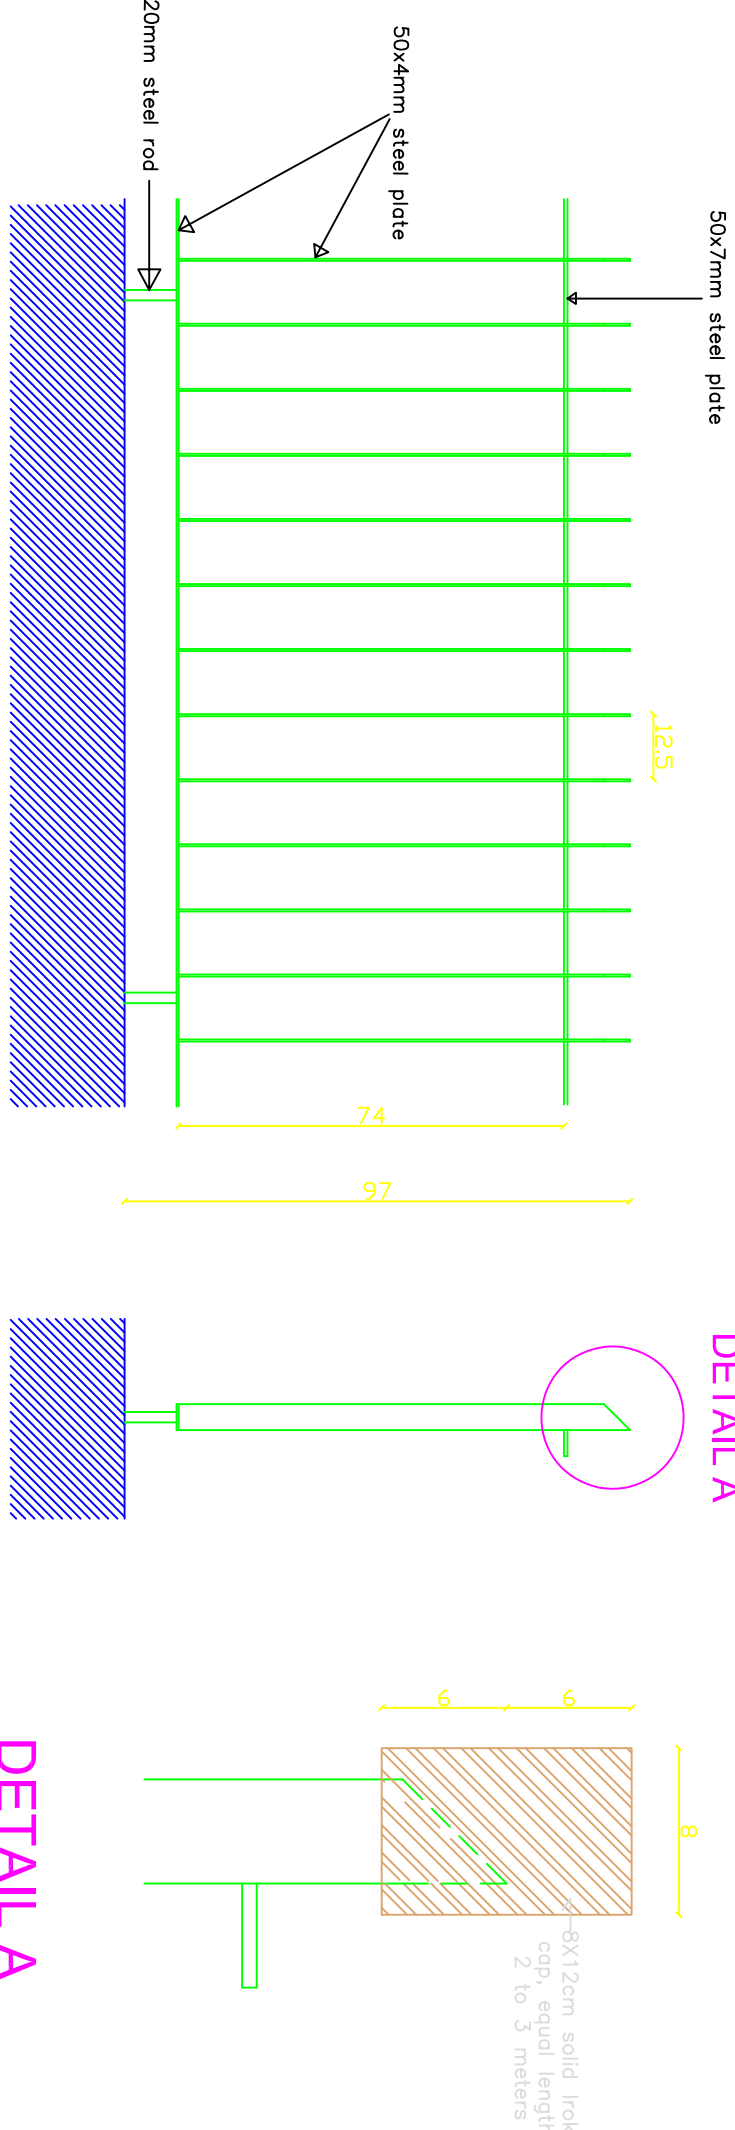


WOOD DOORS SCHEDULE
Scale 1:25 cm

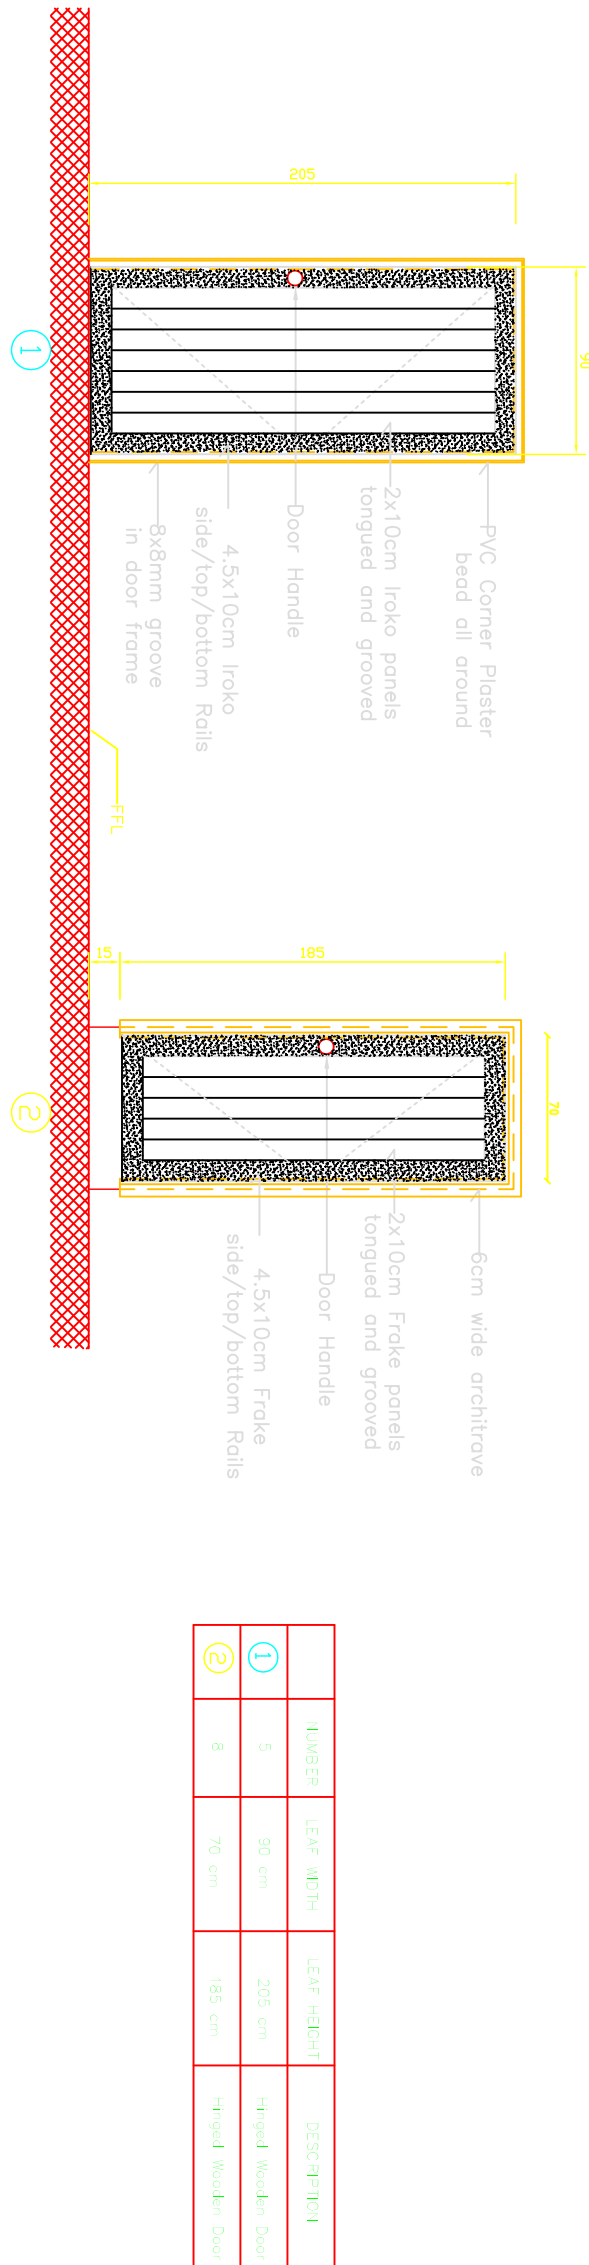


Number	Symbol	Material	Description
1		50x7mm steel plate	For railing, this plate is used to connect the railing to the wall.
2		50x7mm steel plate	For railing, this plate is used to connect the railing to the wall.


GATE A
Scale 1:20 cm

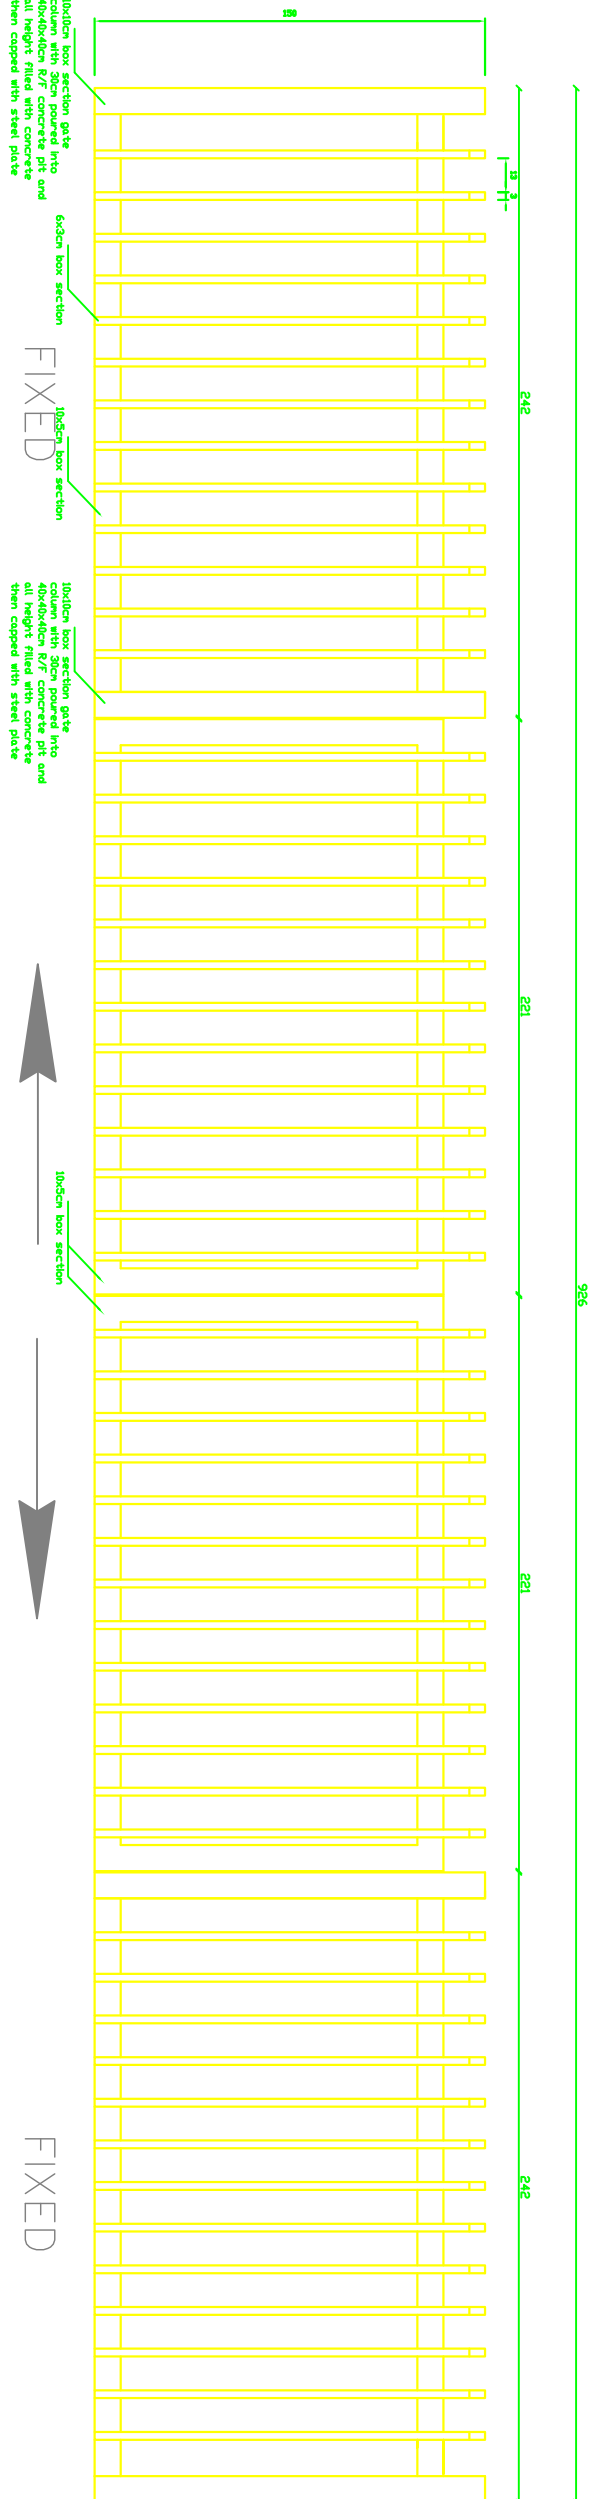


GATE B
Scale 1:20 cm

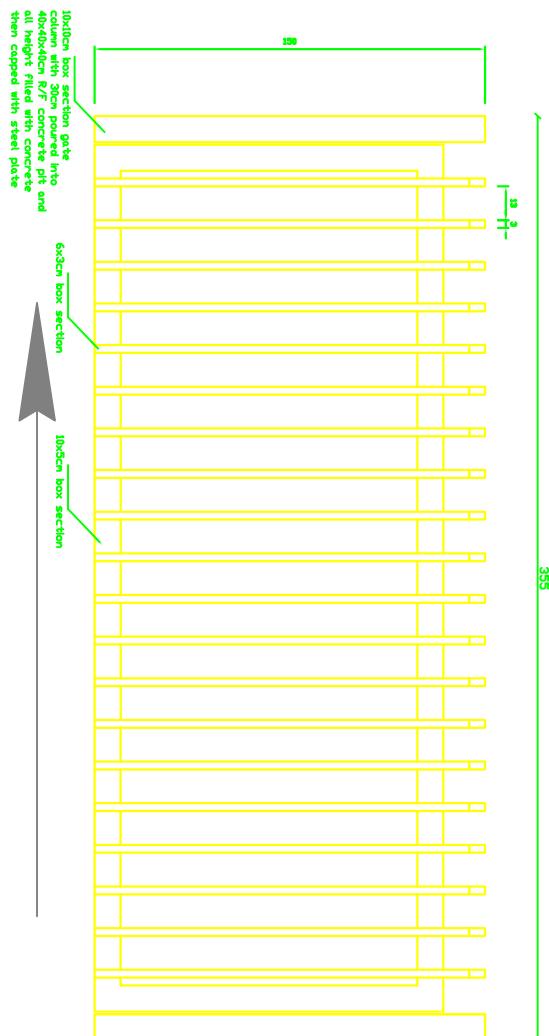


GATE C
Scale 1:20 cm

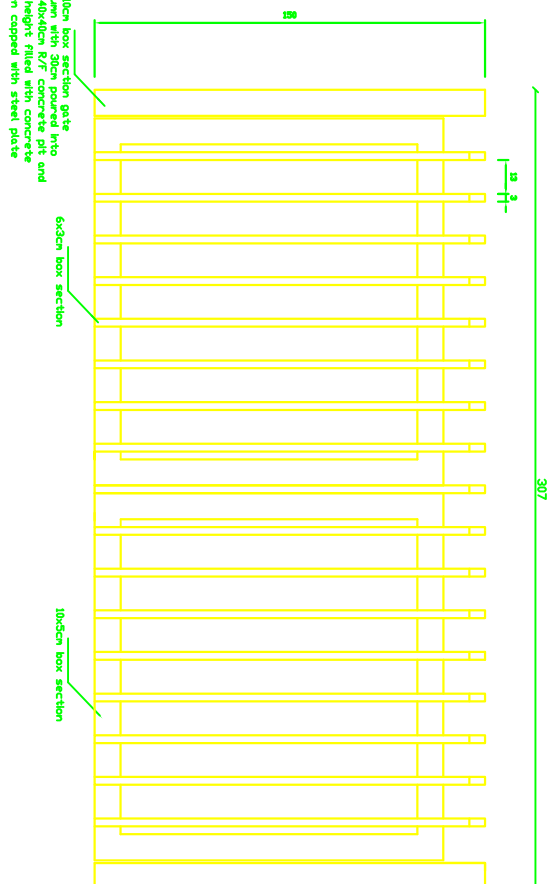

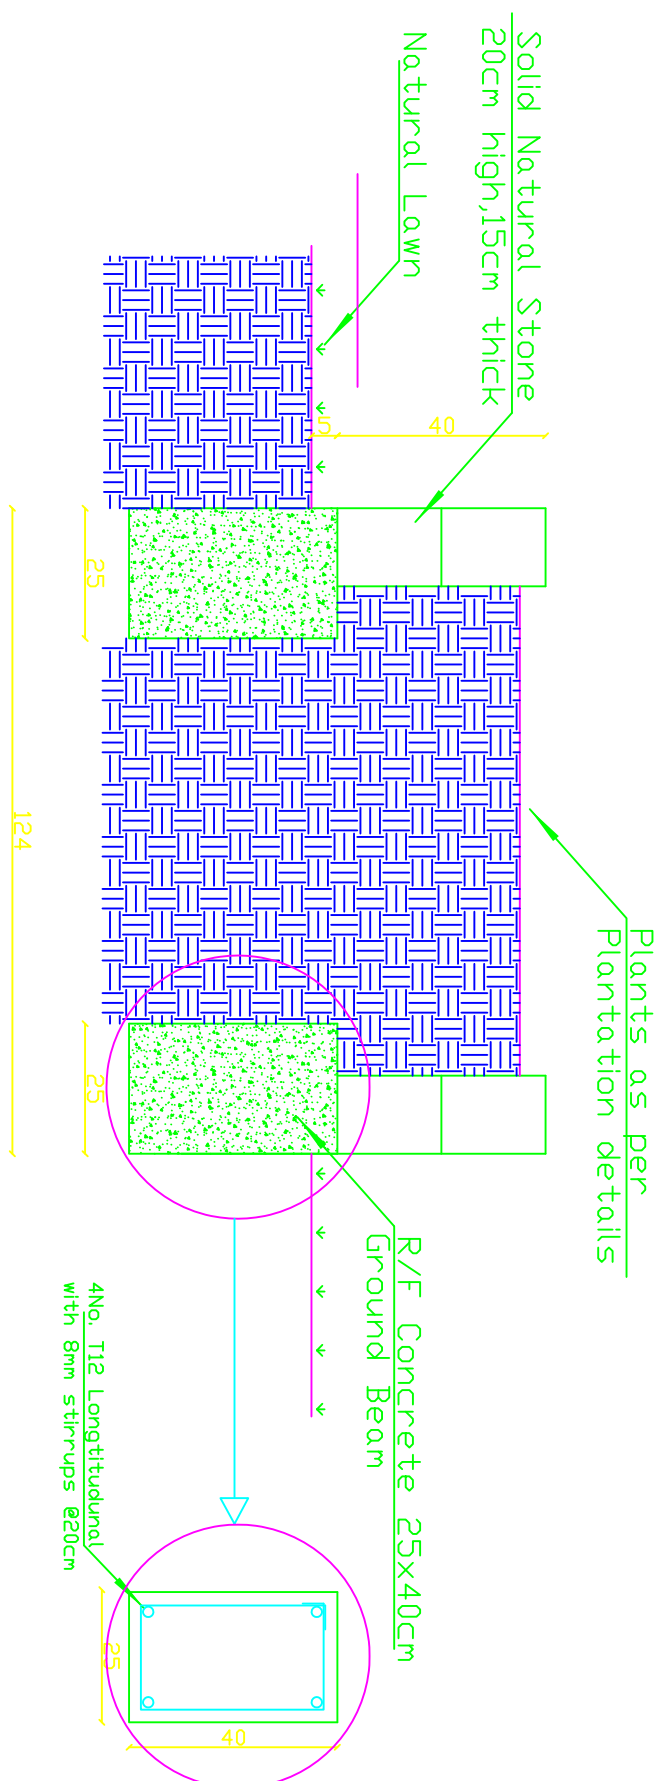


SECTION B-B

Scale 1:10 cm

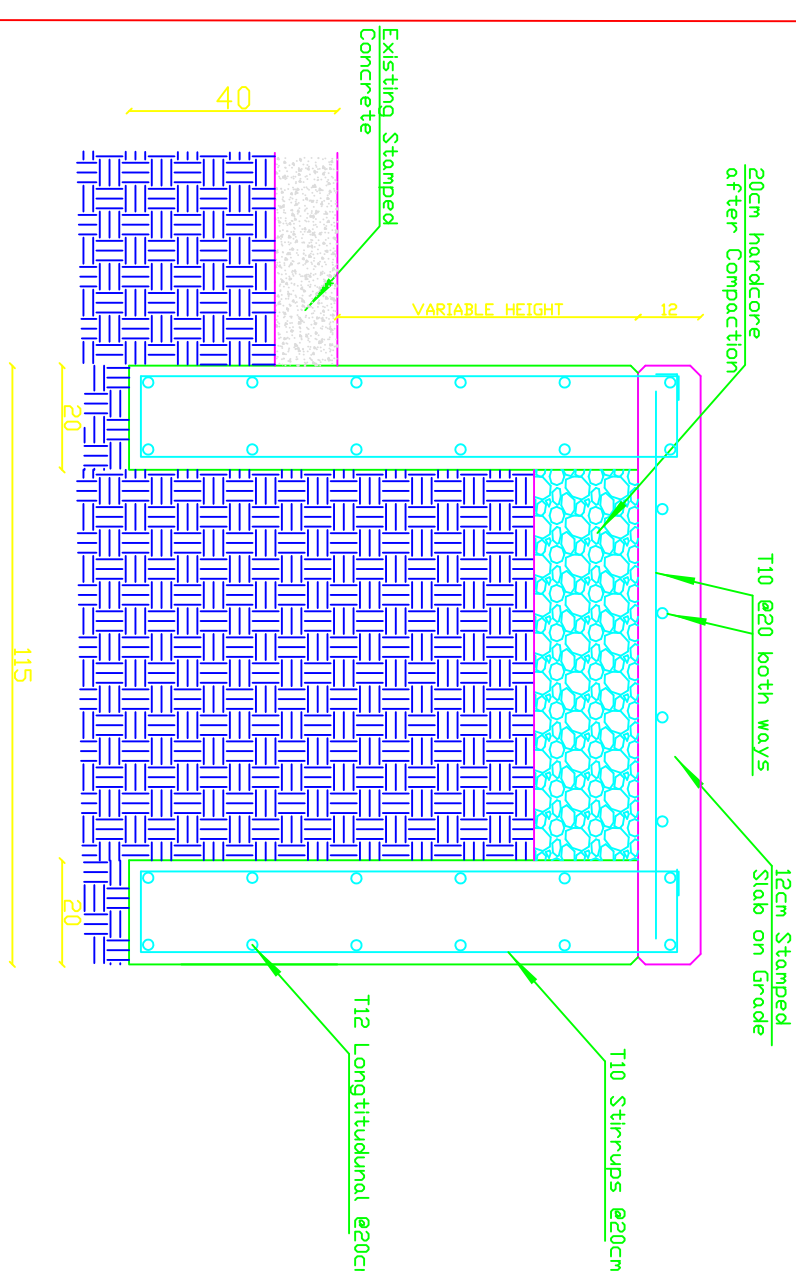


RAMP SECTION

Scale 1:10 cm

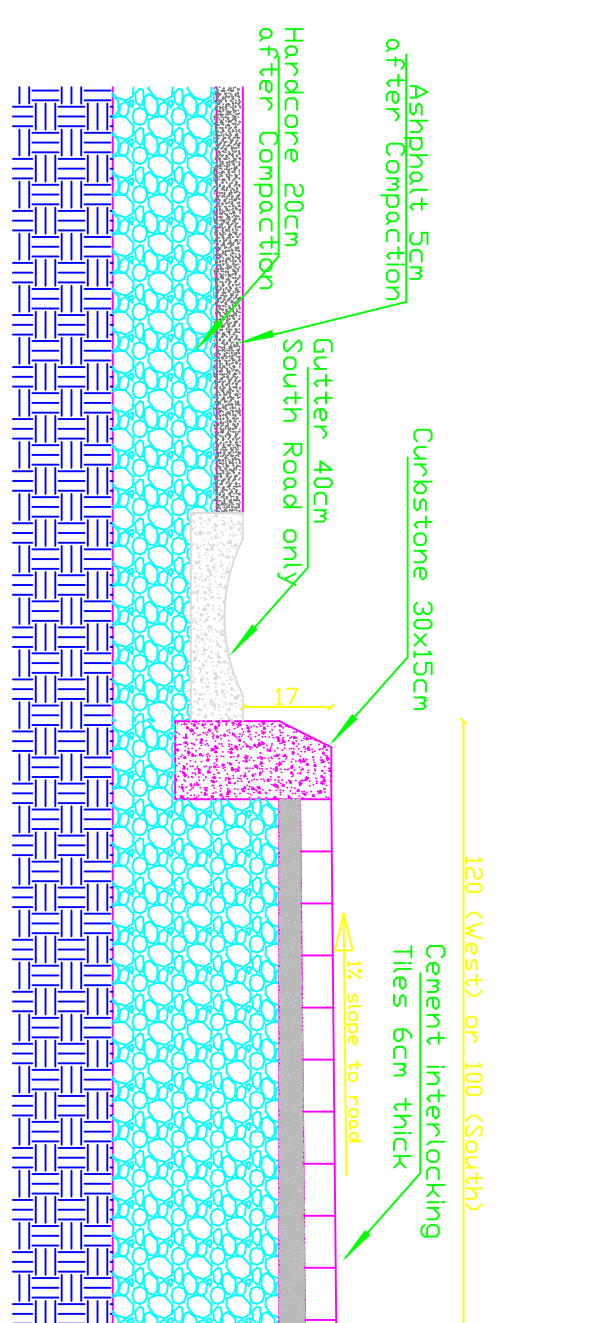

CURBSTONE SECTION

Scale 1:10 cm

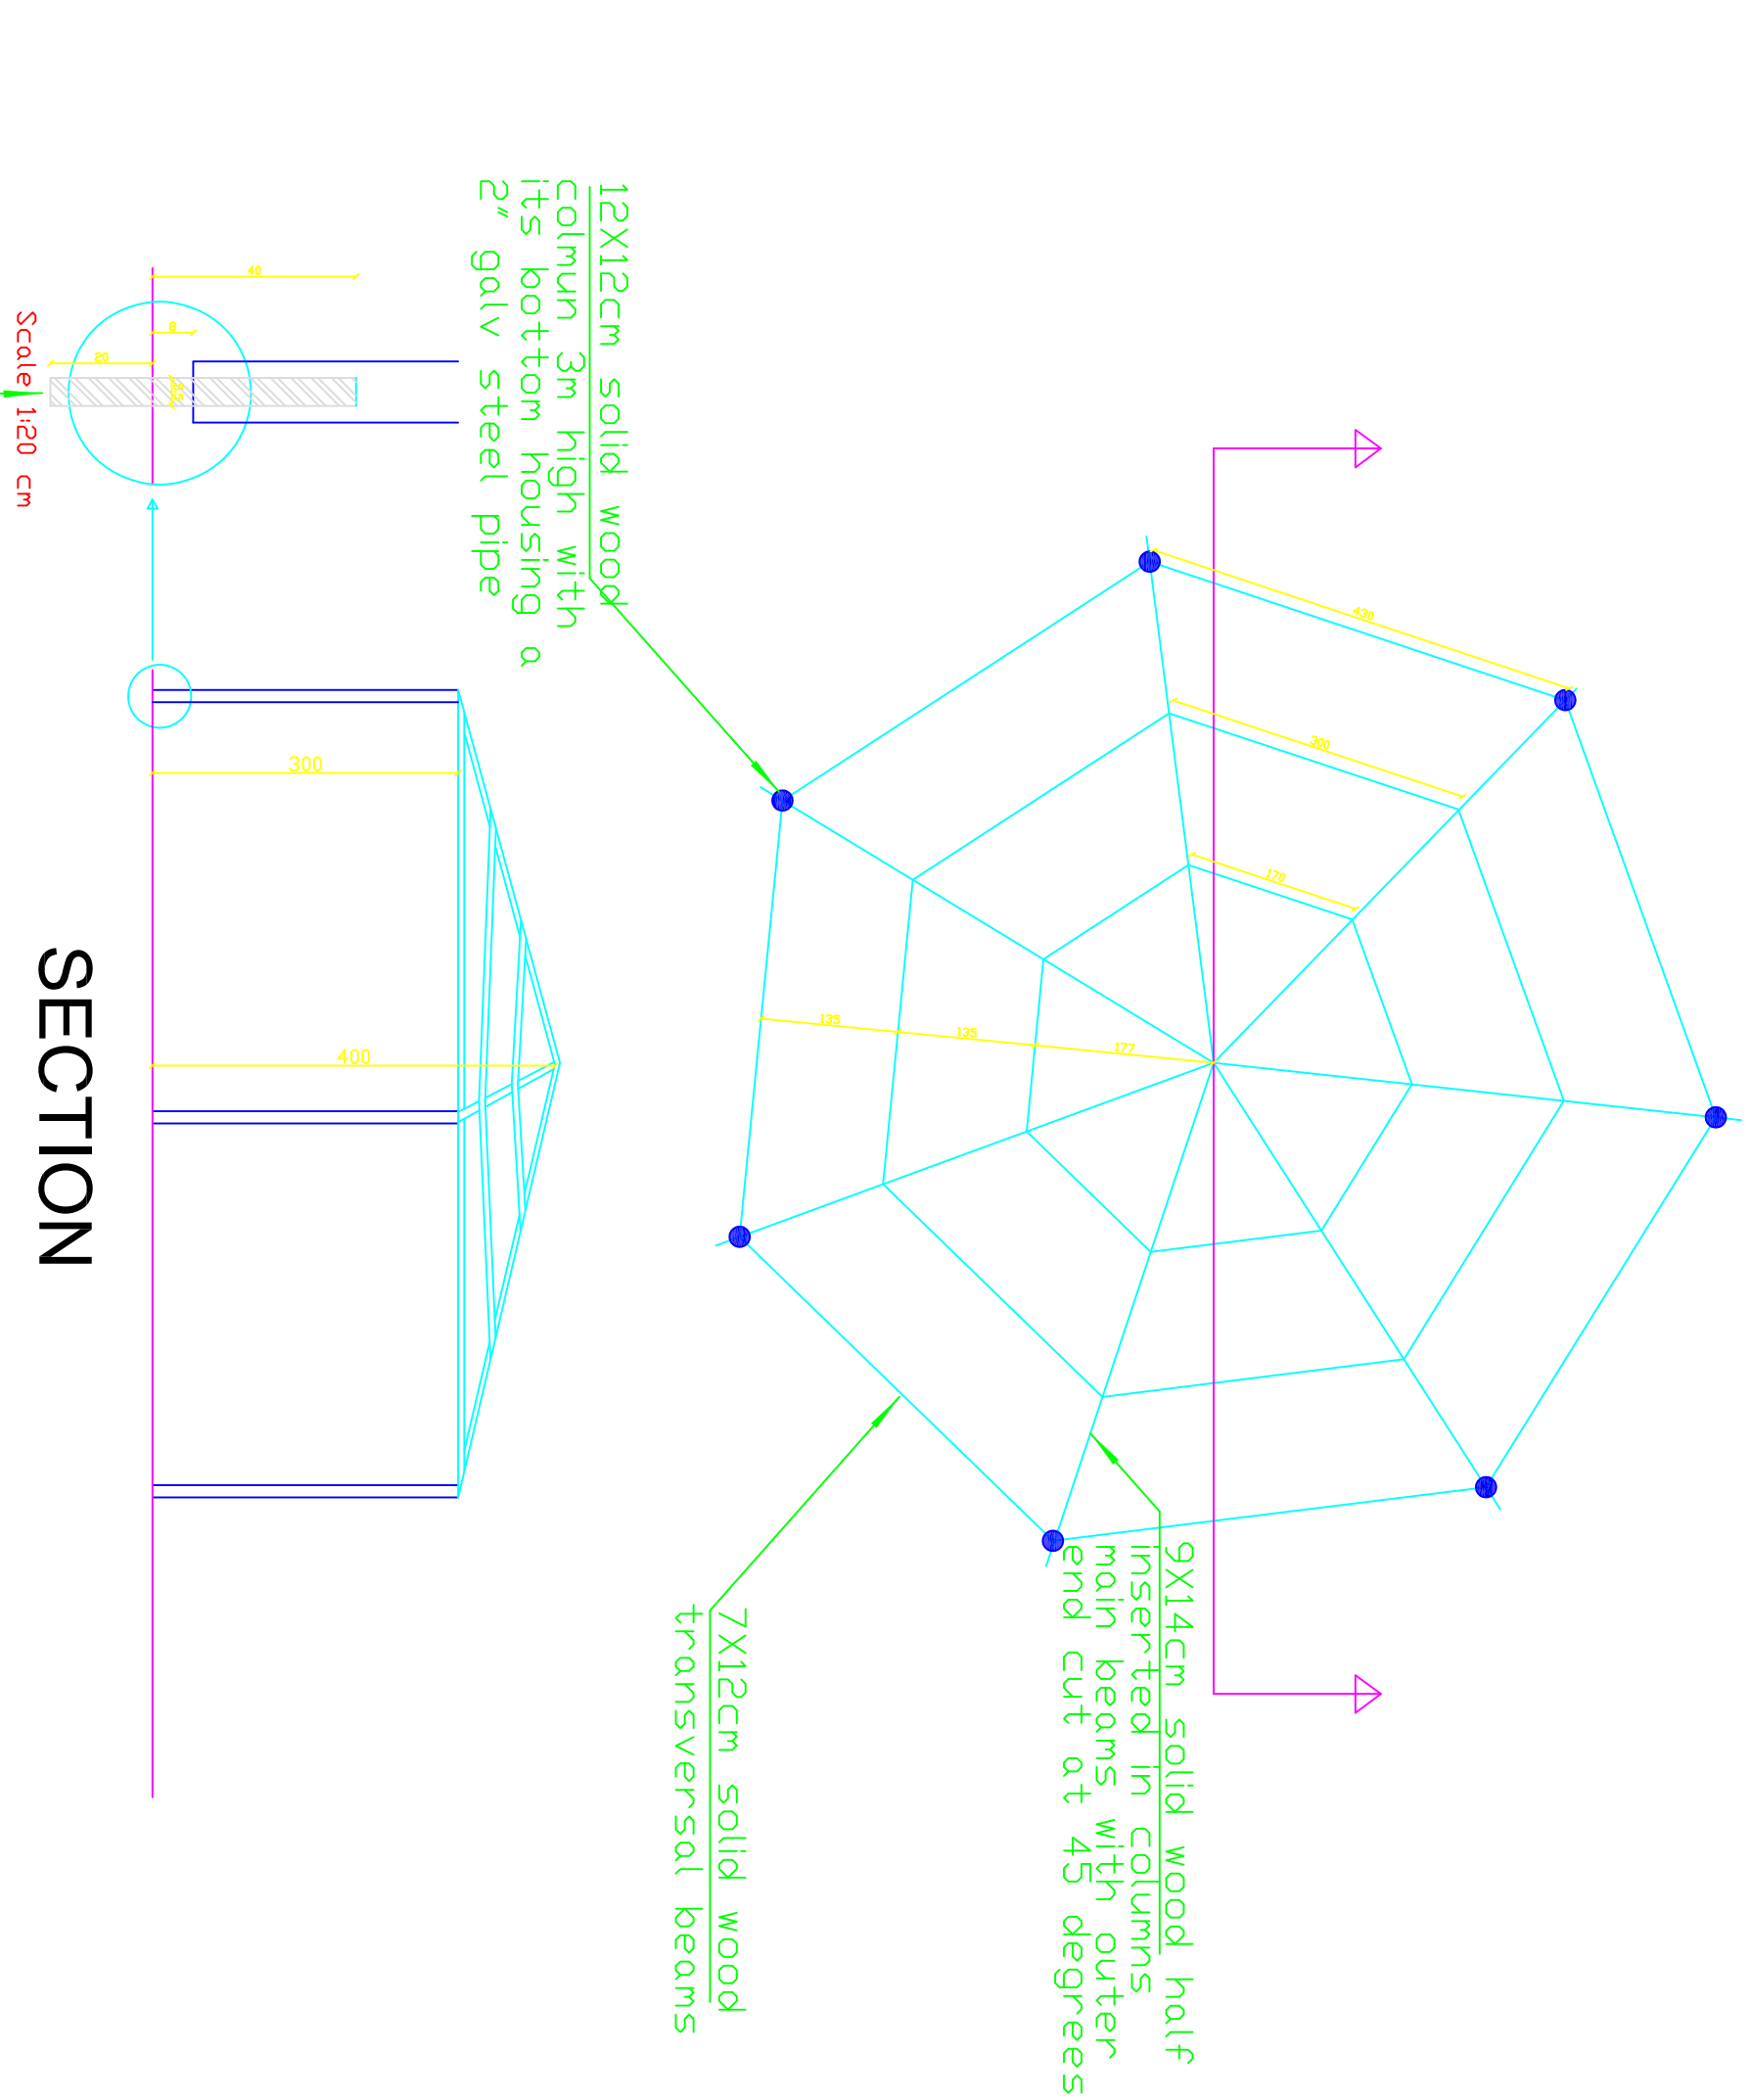


SECTION

Scale 1:20 cm

WOODEN PERGOLA WP1

Scale 1:50 cm

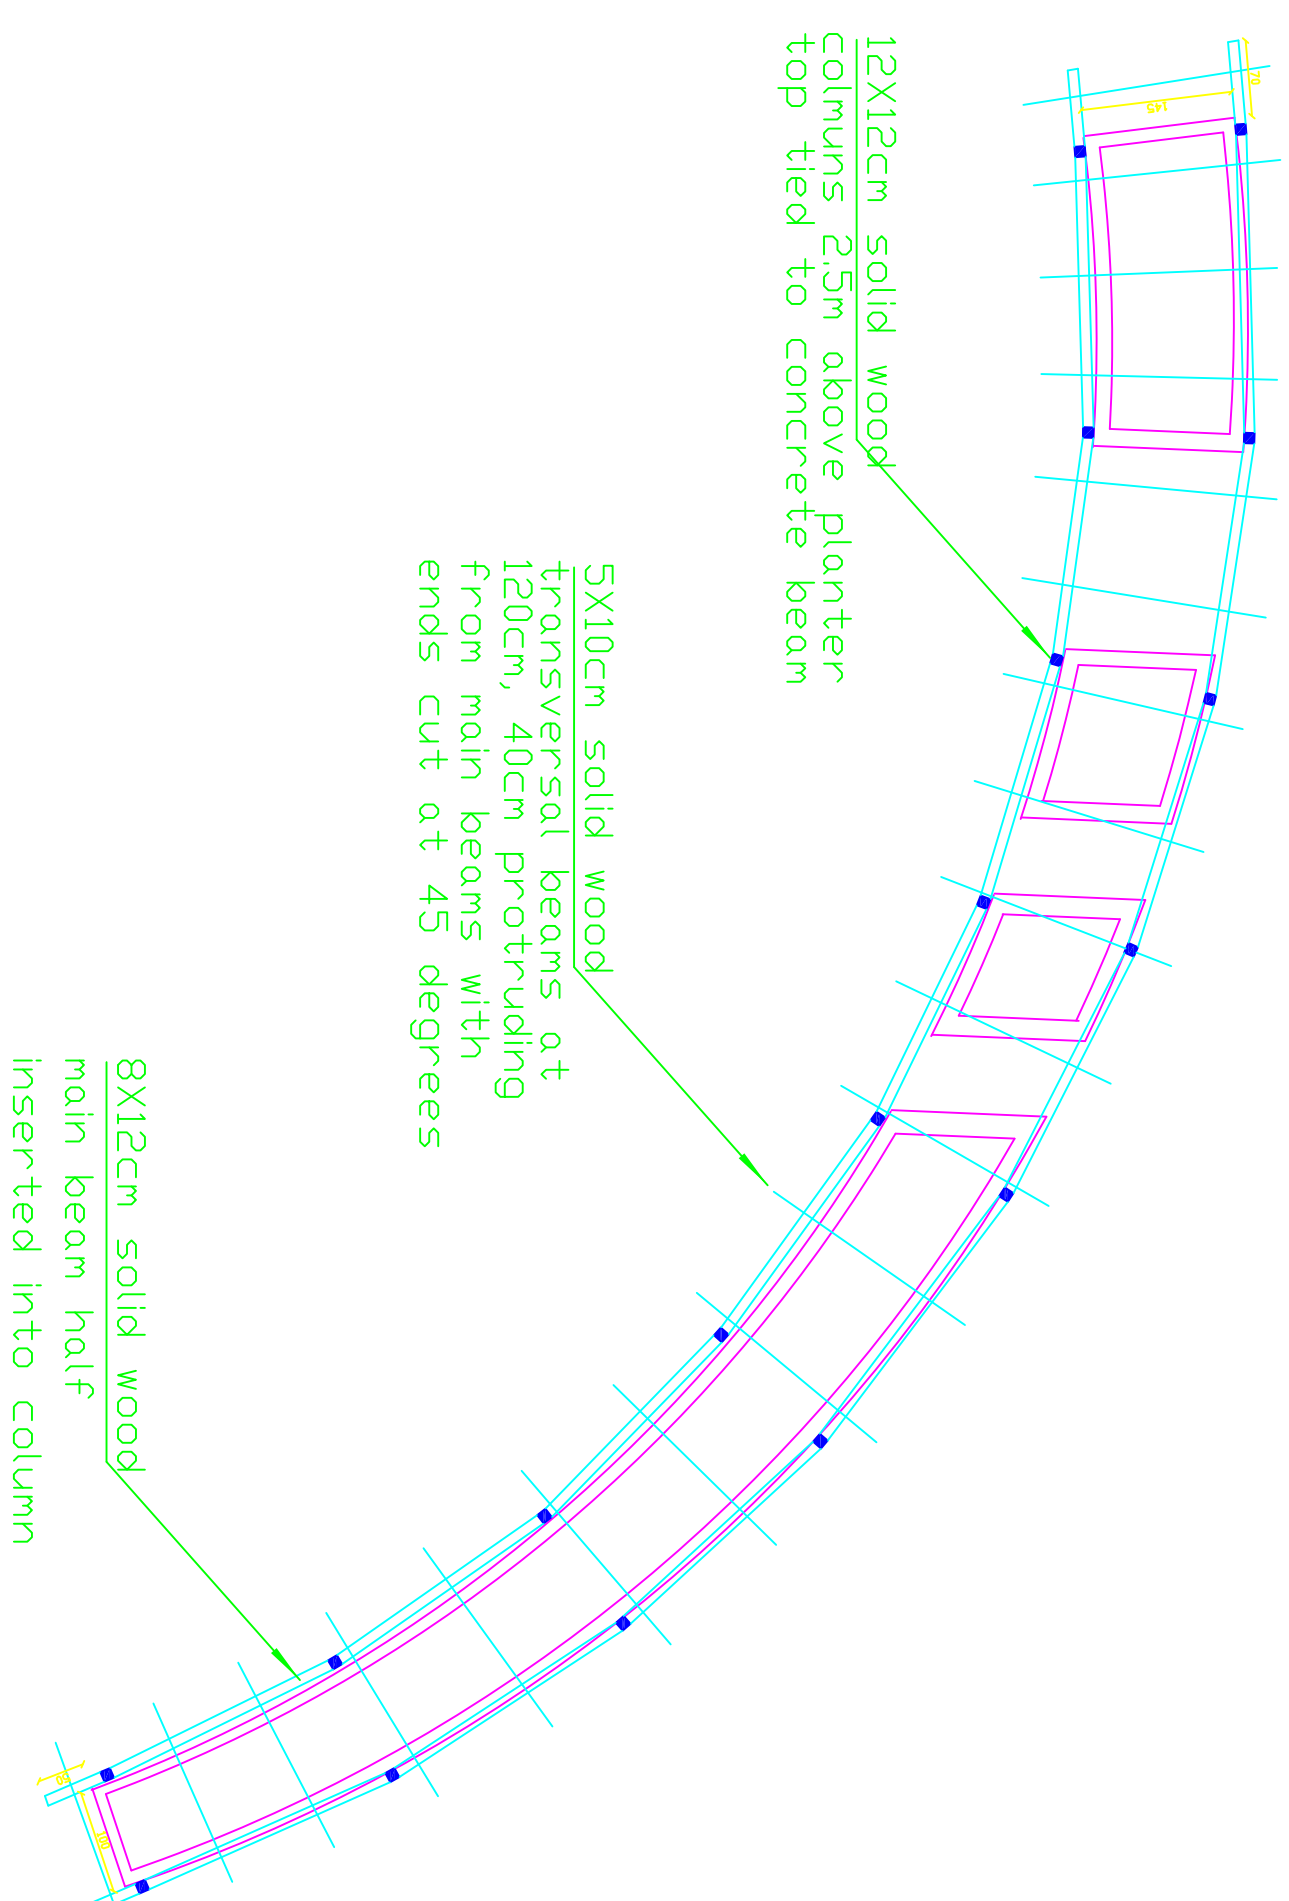


WOODEN PERGOLA WP2

Scale 1:50 cm

KEY PLAN

THIS DRAWING IS A COPYRIGHT. DO NOT SCALE FROM THE DRAWING. THE CONTRACTOR AND HIS SUB-CONTRACTORS ARE TO VERIFY ALL DIMENSIONS ON SITE BEFORE MAKING SHOP DRAWINGS OR COMMENCING MANUFACTURE.

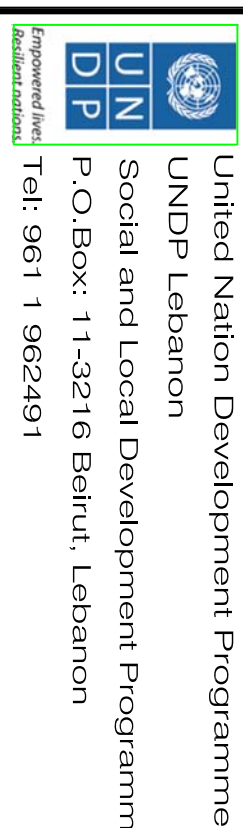

PROGRAMME:

Lebanese Host Communities
Support Programme
Support to Integrated Service
Provision at the Local Level



Supporting Host Communities

PROJECT NAME:

RMEILEH PUBLIC GARDEN

NOTES:

0	---	---	GENERAL REVISION	---
REV	BY	Date	Description	Appr.
PROJECT NBR. ---				
PROJECT PHASE			TENDER	
DISCIPLINE			CIVIL ENGINEERING	
SECTOR				
BUILDING				
DESIGNED ---				
DRAWN ---				
CHECKED ---				
APPROVED				
DATE 07 JANUARY 2017				
SCALE				
SHEET SIZE A1				
Title				


RMEILEH PUBLIC GARDEN

ARCHITECTURAL MISC DETAILS

Sheet 1 OF 1


RP-TD-AR-06-REV.0

Project Number	Phase	Type	Drawing Number	Revision
----------------	-------	------	----------------	----------

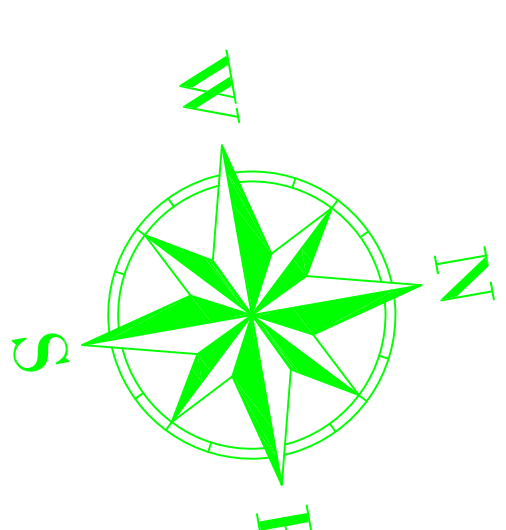

KEY PLAN

THIS DRAWING IS A COPYRIGHT. DO NOT SCALE FROM THE DRAWING. THE CONTRACTOR AND HIS SUB-CONTRACTORS ARE TO VERIFY ALL DIMENSIONS ON SITE BEFORE MAKING SHOP DRAWINGS OR COMMENCING MANUFACTURE.

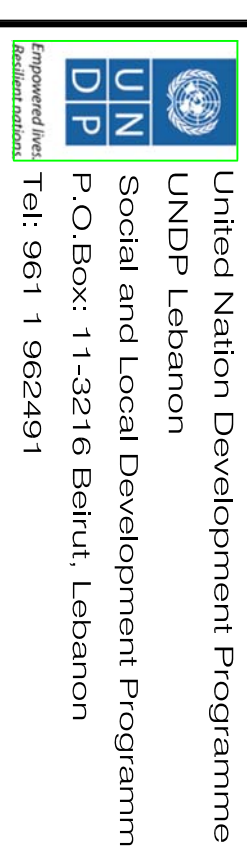

PROGRAMME:

Lebanese Host Communities
Support Programme
Support to Integrated Service
Provision at the Local Level



PROJECT NAME:

RMEILEH PUBLIC GARDEN

NOTES:

It will be the Municipality responsibility to provide for a public water supply source next to the Public Garden West Corner. Connecting that source to the Public Garden water tanks shall be part of the scope of works of the Contractor.

0	---	---	GENERAL REVISION	---
REV BY	Date	Description	Appr	
PROJECT NBR. ---				
PROJECT PHASE TENDER				
DISCIPLINE CIVIL ENGINEERING				
SECTOR				
BUILDING				
DESIGNED ---				
DRAWN ---				
CHECKED ---				
APPROVED				
DATE 07 JANUARY 2017				
SCALE 1:100cm				
SHEET SIZE A1				
Title				


RMEILEH PUBLIC GARDEN

WATER SUPPLY / DRAINAGE LAYOUT

Sheet 1 OF 1

RP-TD-ME-01-REV.0

Project Number	Phase	Type	Drawing Number	Revision
----------------	-------	------	----------------	----------

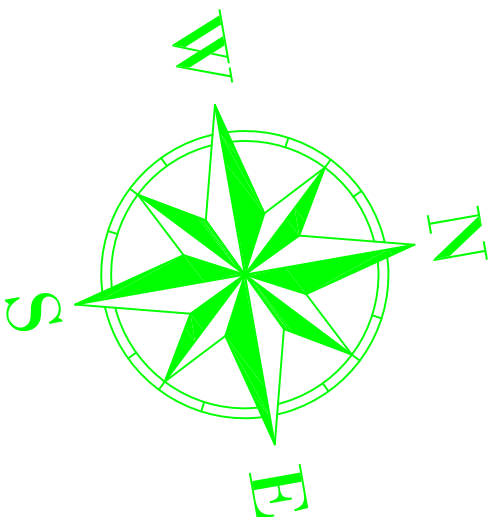

KEY PLAN

THIS DRAWING IS A COPYRIGHT. DO NOT SCALE FROM THE DRAWING. THE CONTRACTOR AND HIS SUB-CONTRACTORS ARE TO VERIFY ALL DIMENSIONS ON SITE BEFORE MAKING SHOP DRAWINGS OR COMMENCING MANUFACTURE.

United Nation Development Programme
UNDP Lebanon
Social and Local Development Programme
P.O. Box : 11-3216 Beirut, Lebanon
Tel: 961 1 962491

PROGRAMME: Lebanese Host Communities
Support Programme
Support to Integrated Service
Provision at the Local Level

PROJECT NAME:

RMEILEH PUBLIC GARDEN

NOTES:

0	---	---	GENERAL REVISION	---
REV	BY	Date	Description	Appr.
PROJECT NBR. ---				
PROJECT PHASE TENDER				
DISCIPLINE CIVIL ENGINEERING				
SECTOR				
BUILDING				
DESIGNED ---				
DRAWN ---				
CHECKED ---				
APPROVED				
DATE 07 JANUARY 2017				
SCALE 1:100cm				
SHEET SIZE A1				
Title				

RMEILEH PUBLIC GARDEN

ELECTRICAL LAYOUT

Sheet 1 OF 1

RP-TD-EL-02-REV.0

Project Number | Phase | Type | Drawing Number | Revision