

KEY PLAN

THIS DRAWING IS A COPYRIGHT. DO NOT SCALE FROM THE DRAWING. THE CONTRACTOR AND HIS SUB-CONTRACTORS ARE TO VERIFY ALL DIMENSIONS ON SITE BEFORE MAKING SHOP DRAWINGS OR COMMENCING MANUFACTURE.

United Nation Development Programme
UNDP Lebanon
Social and Local Development Programme
P.O.Box: 11-3216 Beirut, Lebanon
Tel: 961 1 962491

PROGRAMME: Lebanese Host Communities Support Programme
Support to Integrated Service Provision at the Local Level

PROJECT NAME:

PUBLIC GARDEN - CHIAH

NOTES:

THIS DRAWING MUST BE READ IN COMBINATION WITH ALL OTHER ARCHITECTURAL AND ENGINEERING DRAWINGS. ALL DIMENSIONS ARE IN CM. ALL PIPES PASSING THROUGH THE POOL TANK WALLS SHALL BE WITH PUDDLE FLANGES

LEGEND:

ROOM NUMBER:
FLOOR NUMBER

CEILING
FLOOR
SKIRTING / HEIGHT
DRAWING NUMBER



0	---	GENERAL REVISION	---
REV BY	Date	Description	Appr.
PROJECT NBR.	---	PROJECT PHASE	TENDER
DISCIPLINE	ARCHITECTURAL	DESIGNED	M.B.
BUILDING	M.B.	DRAWN	M.B.
CHECKED	---	APPROVED	---
DATE	20-02-2017	SCALE	1/100
SHEET SIZE	A1	ME102	

MECHANICAL PLAN LAYOUT DRAINAGE PLAN



PH1-RH-ME102-REV.0

Sheet 1 OF 1	Project Number	Phase	Type	Drawing Number	Revision
--------------	----------------	-------	------	----------------	----------

BUILDINGS 1 & 2-

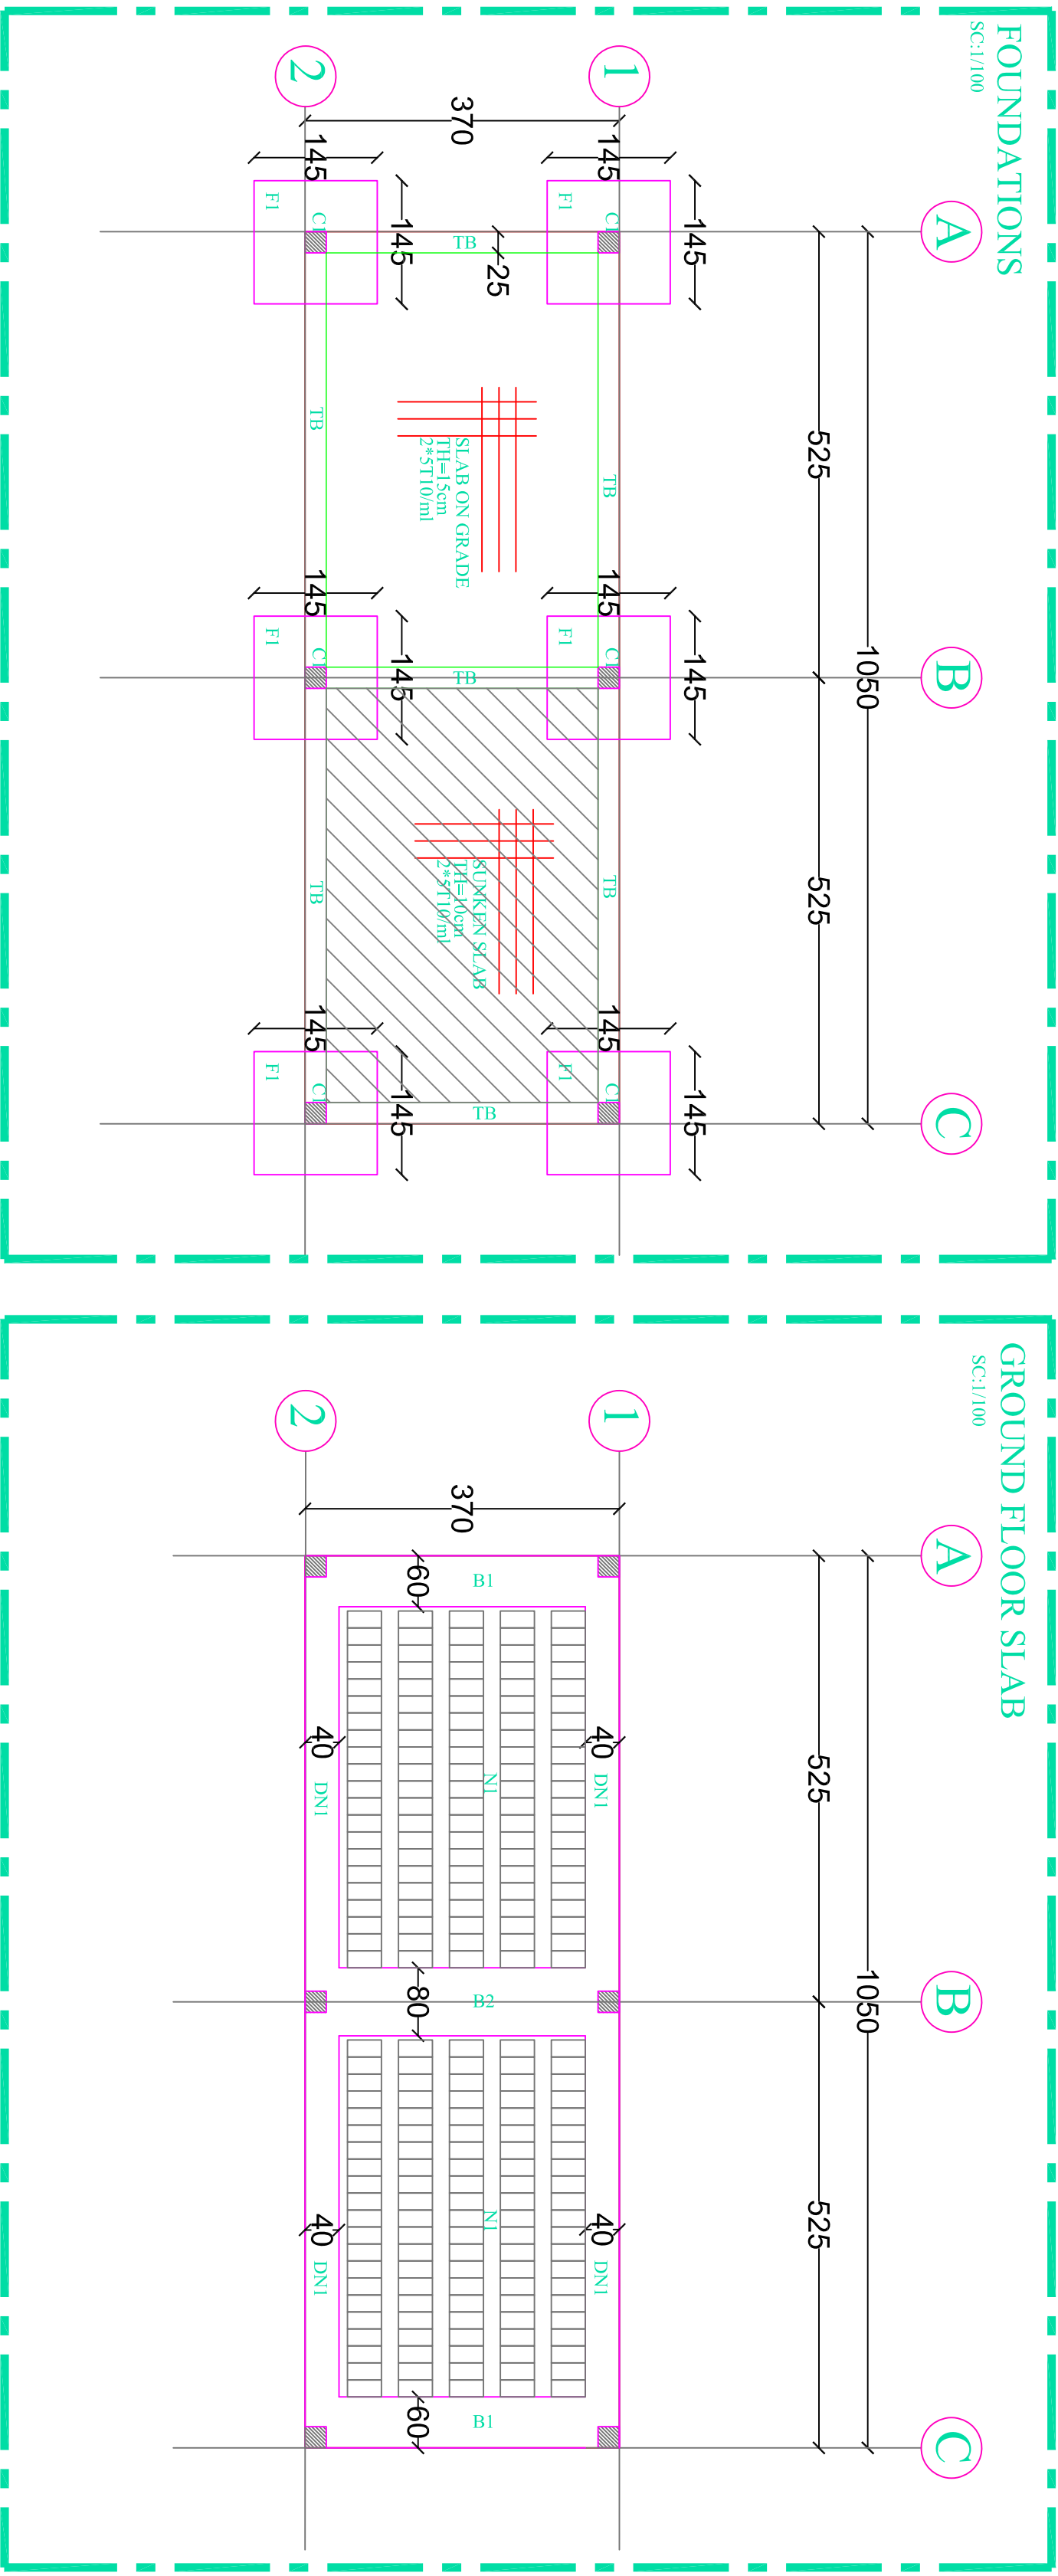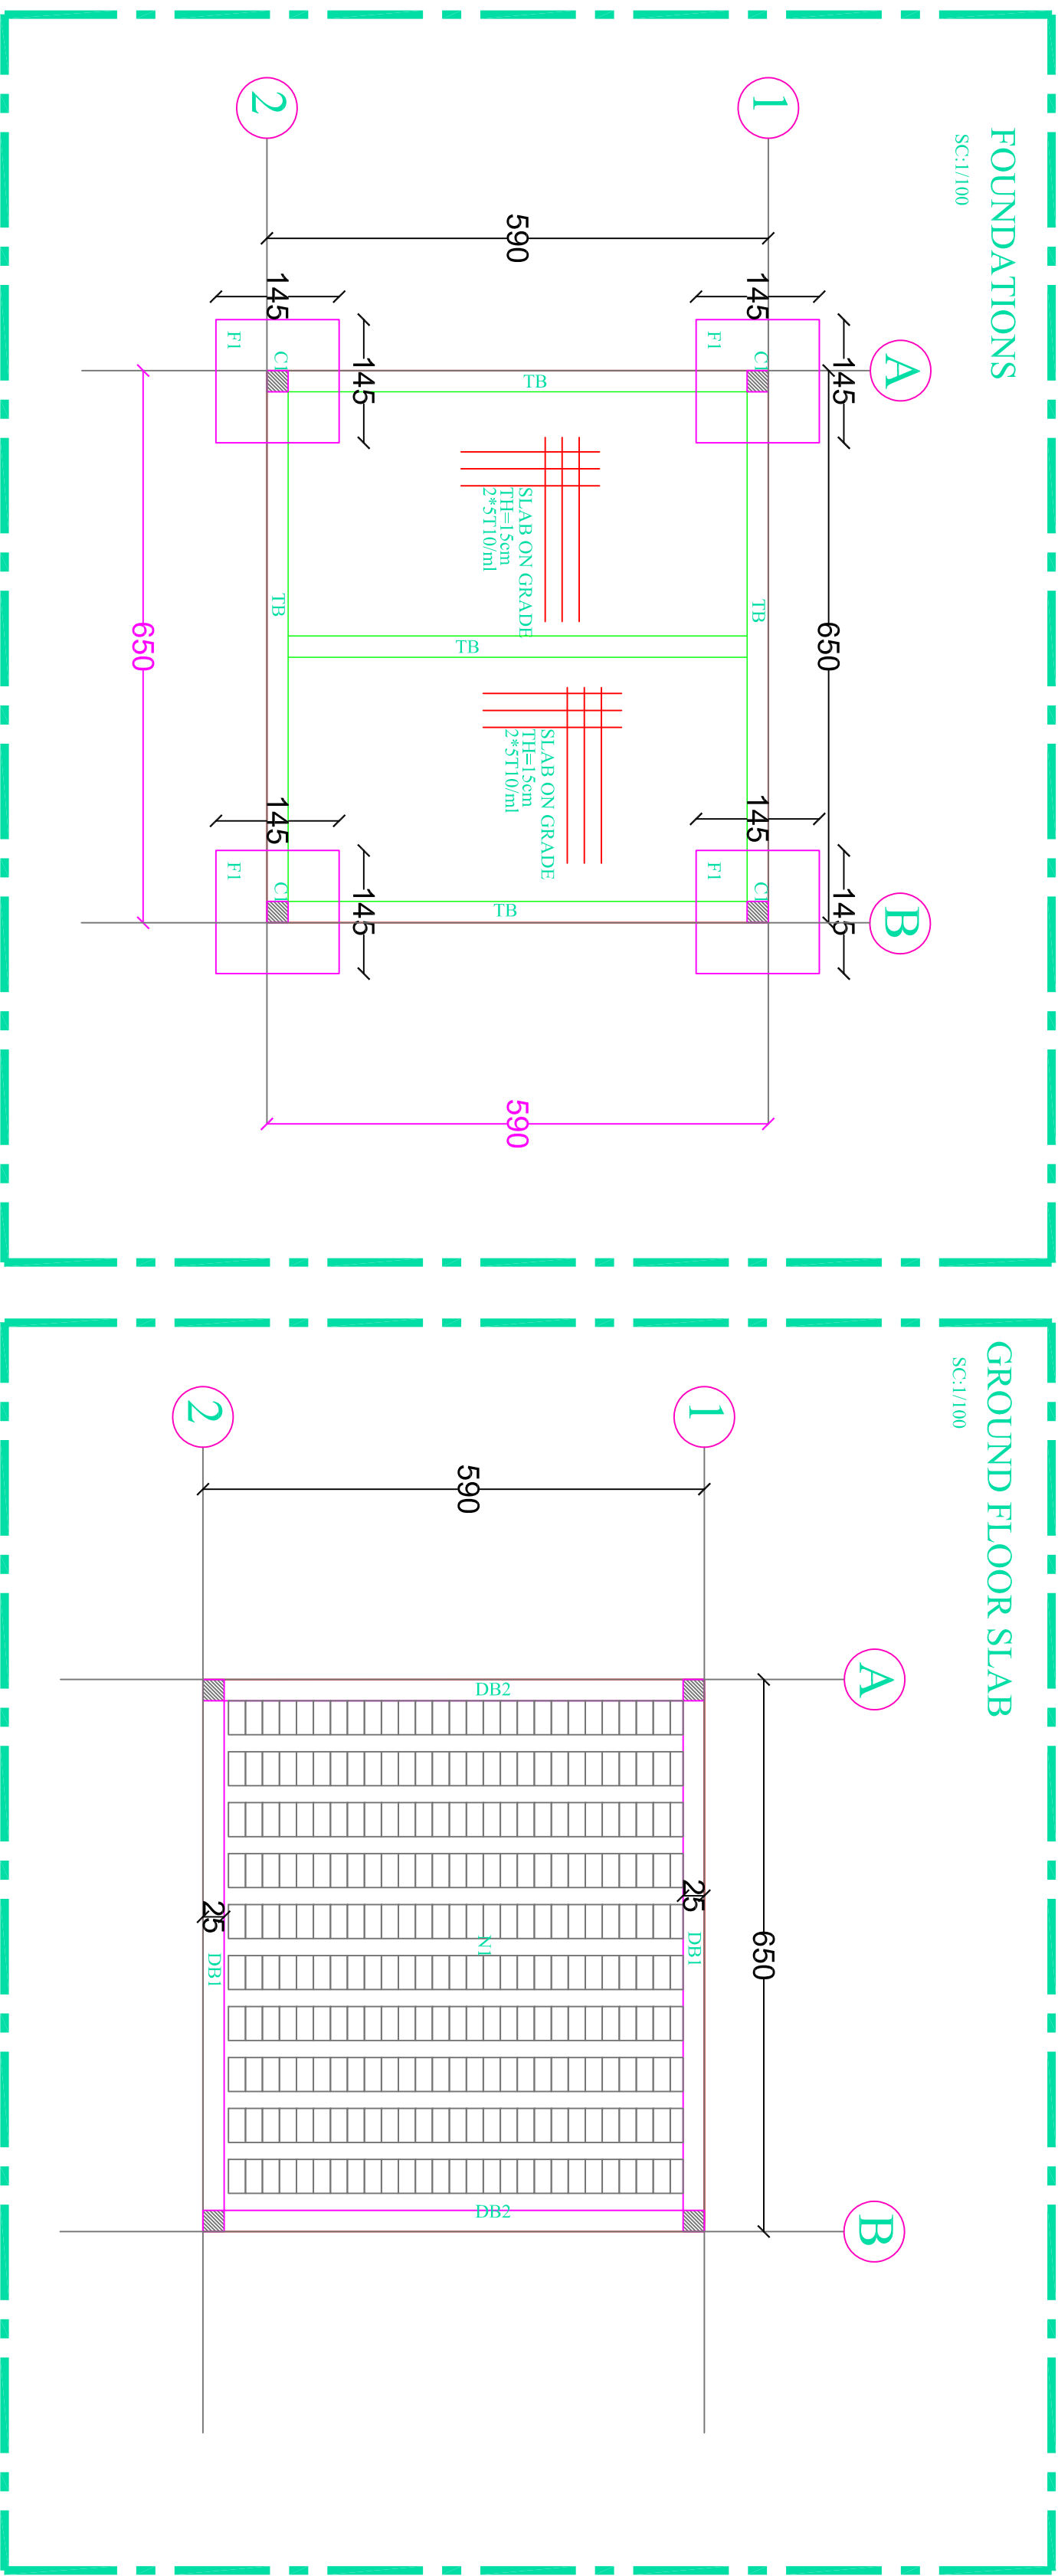

BUILDING 3-

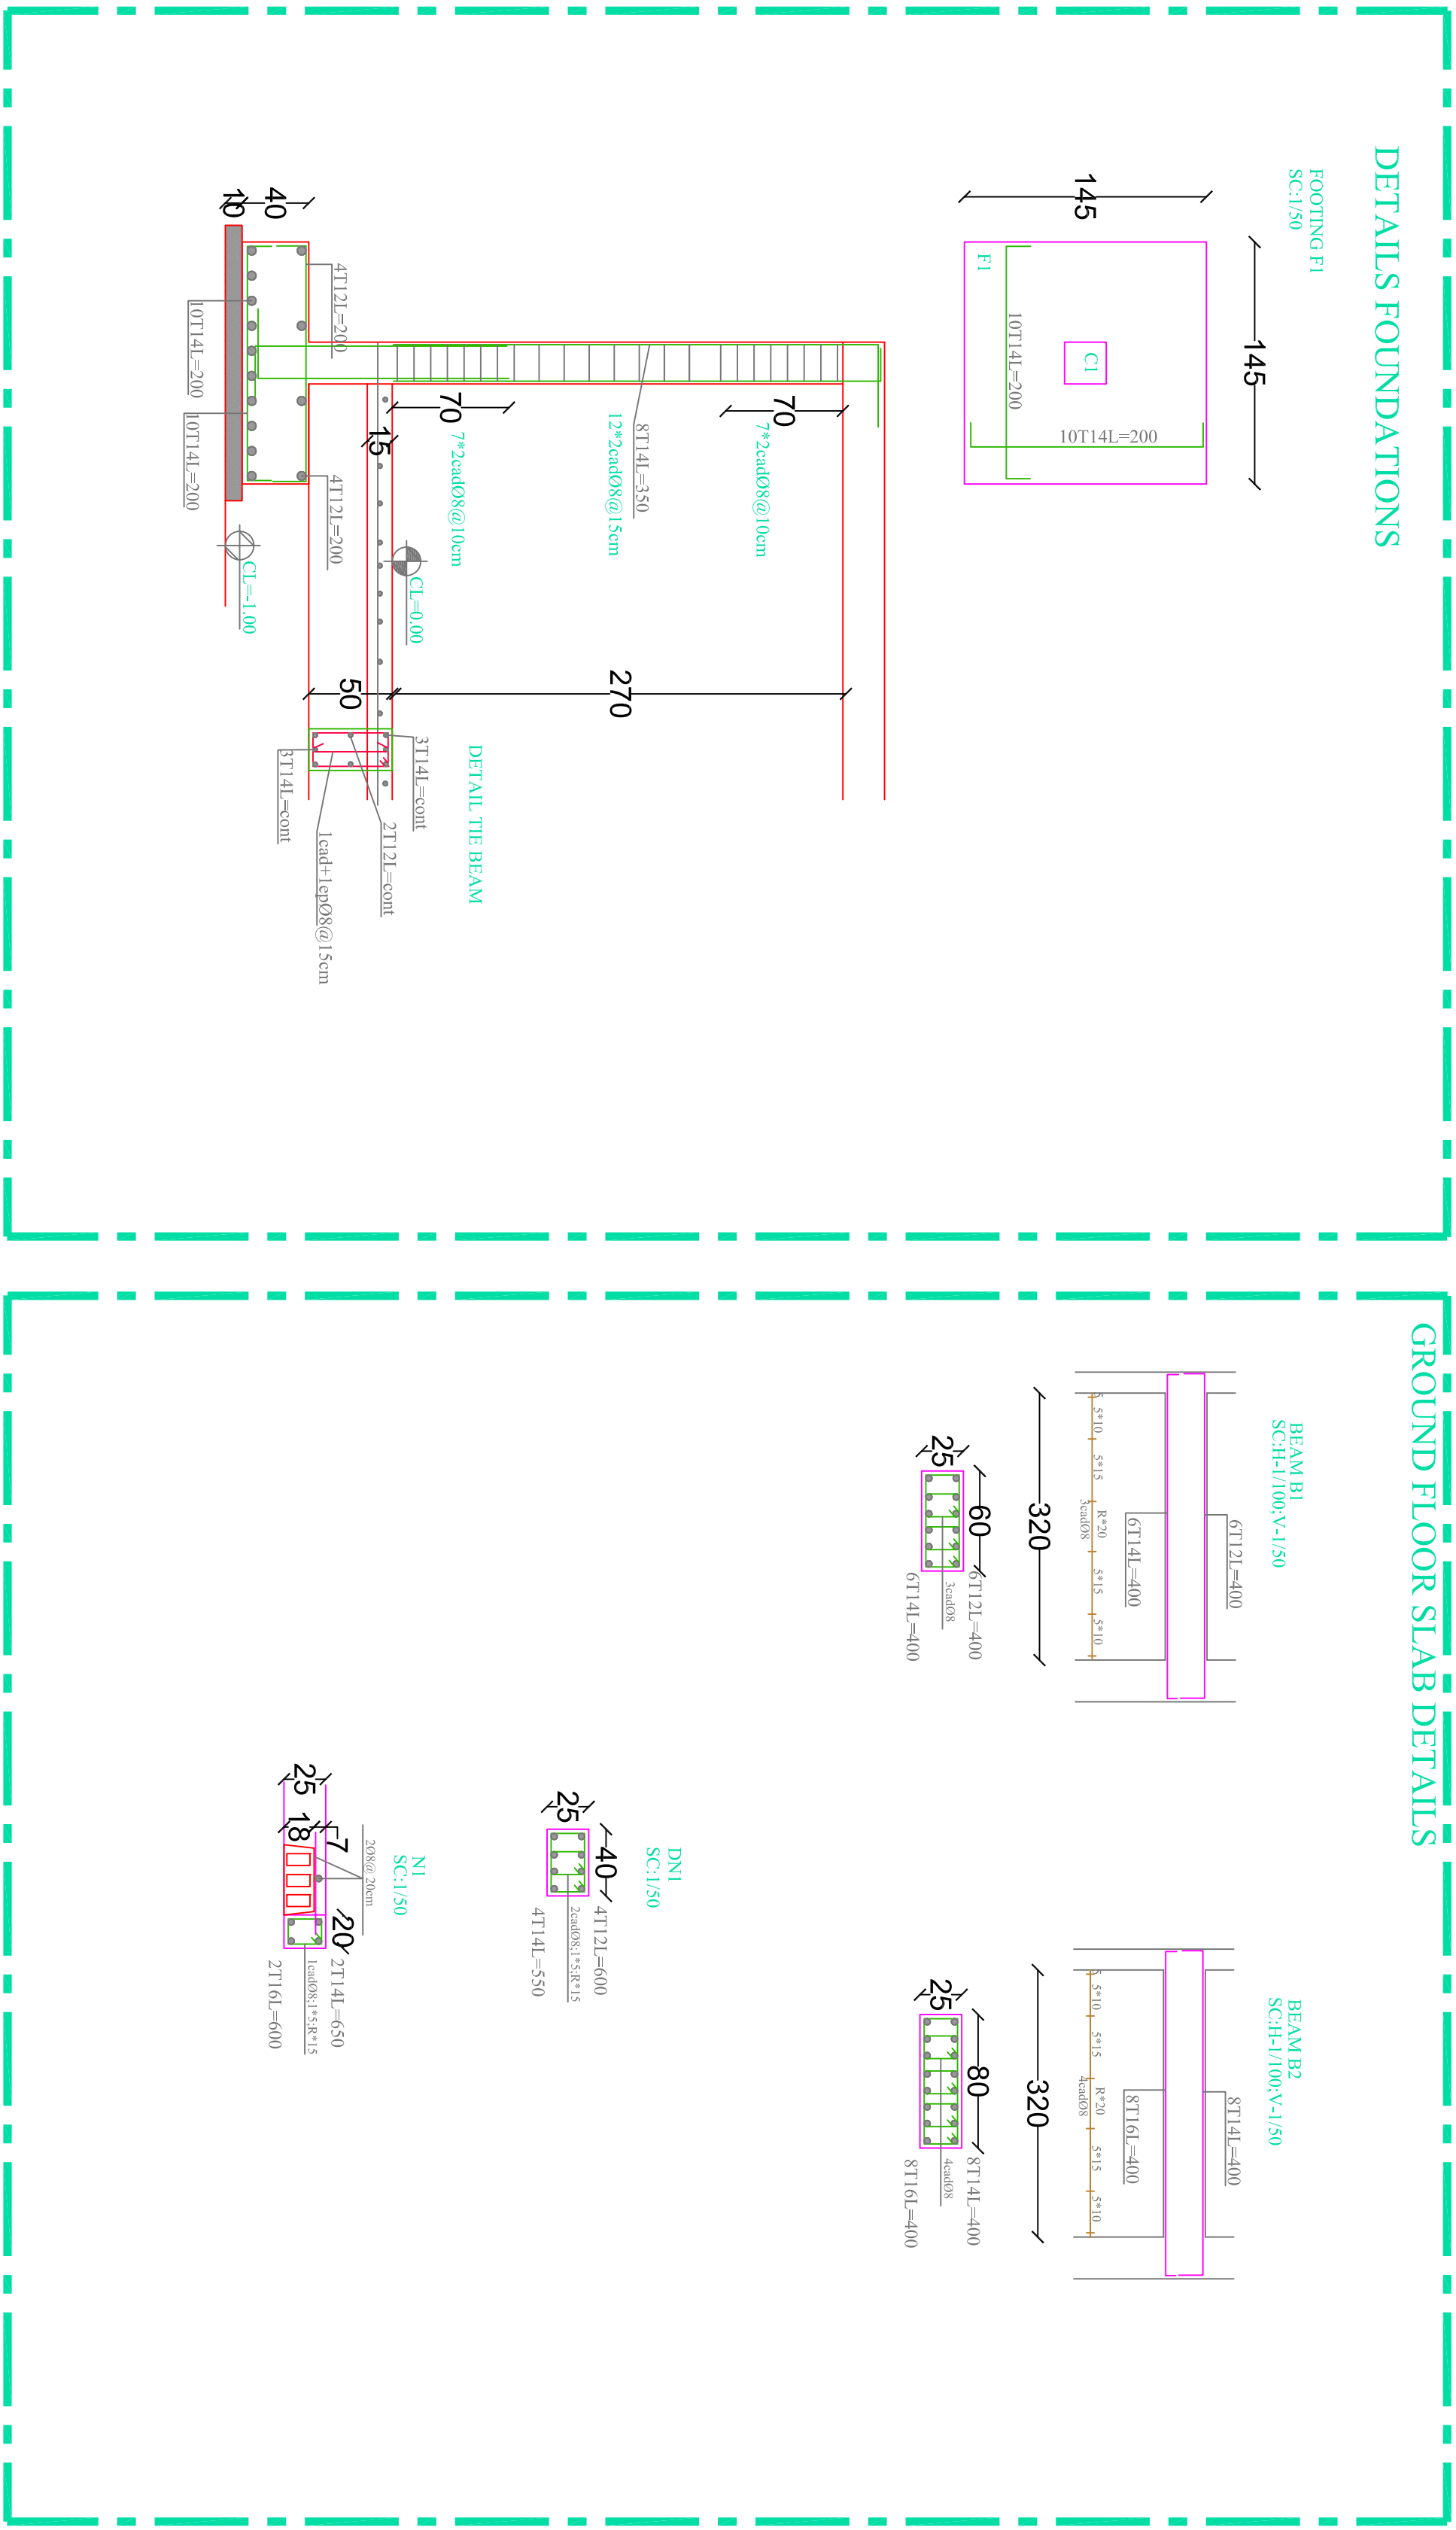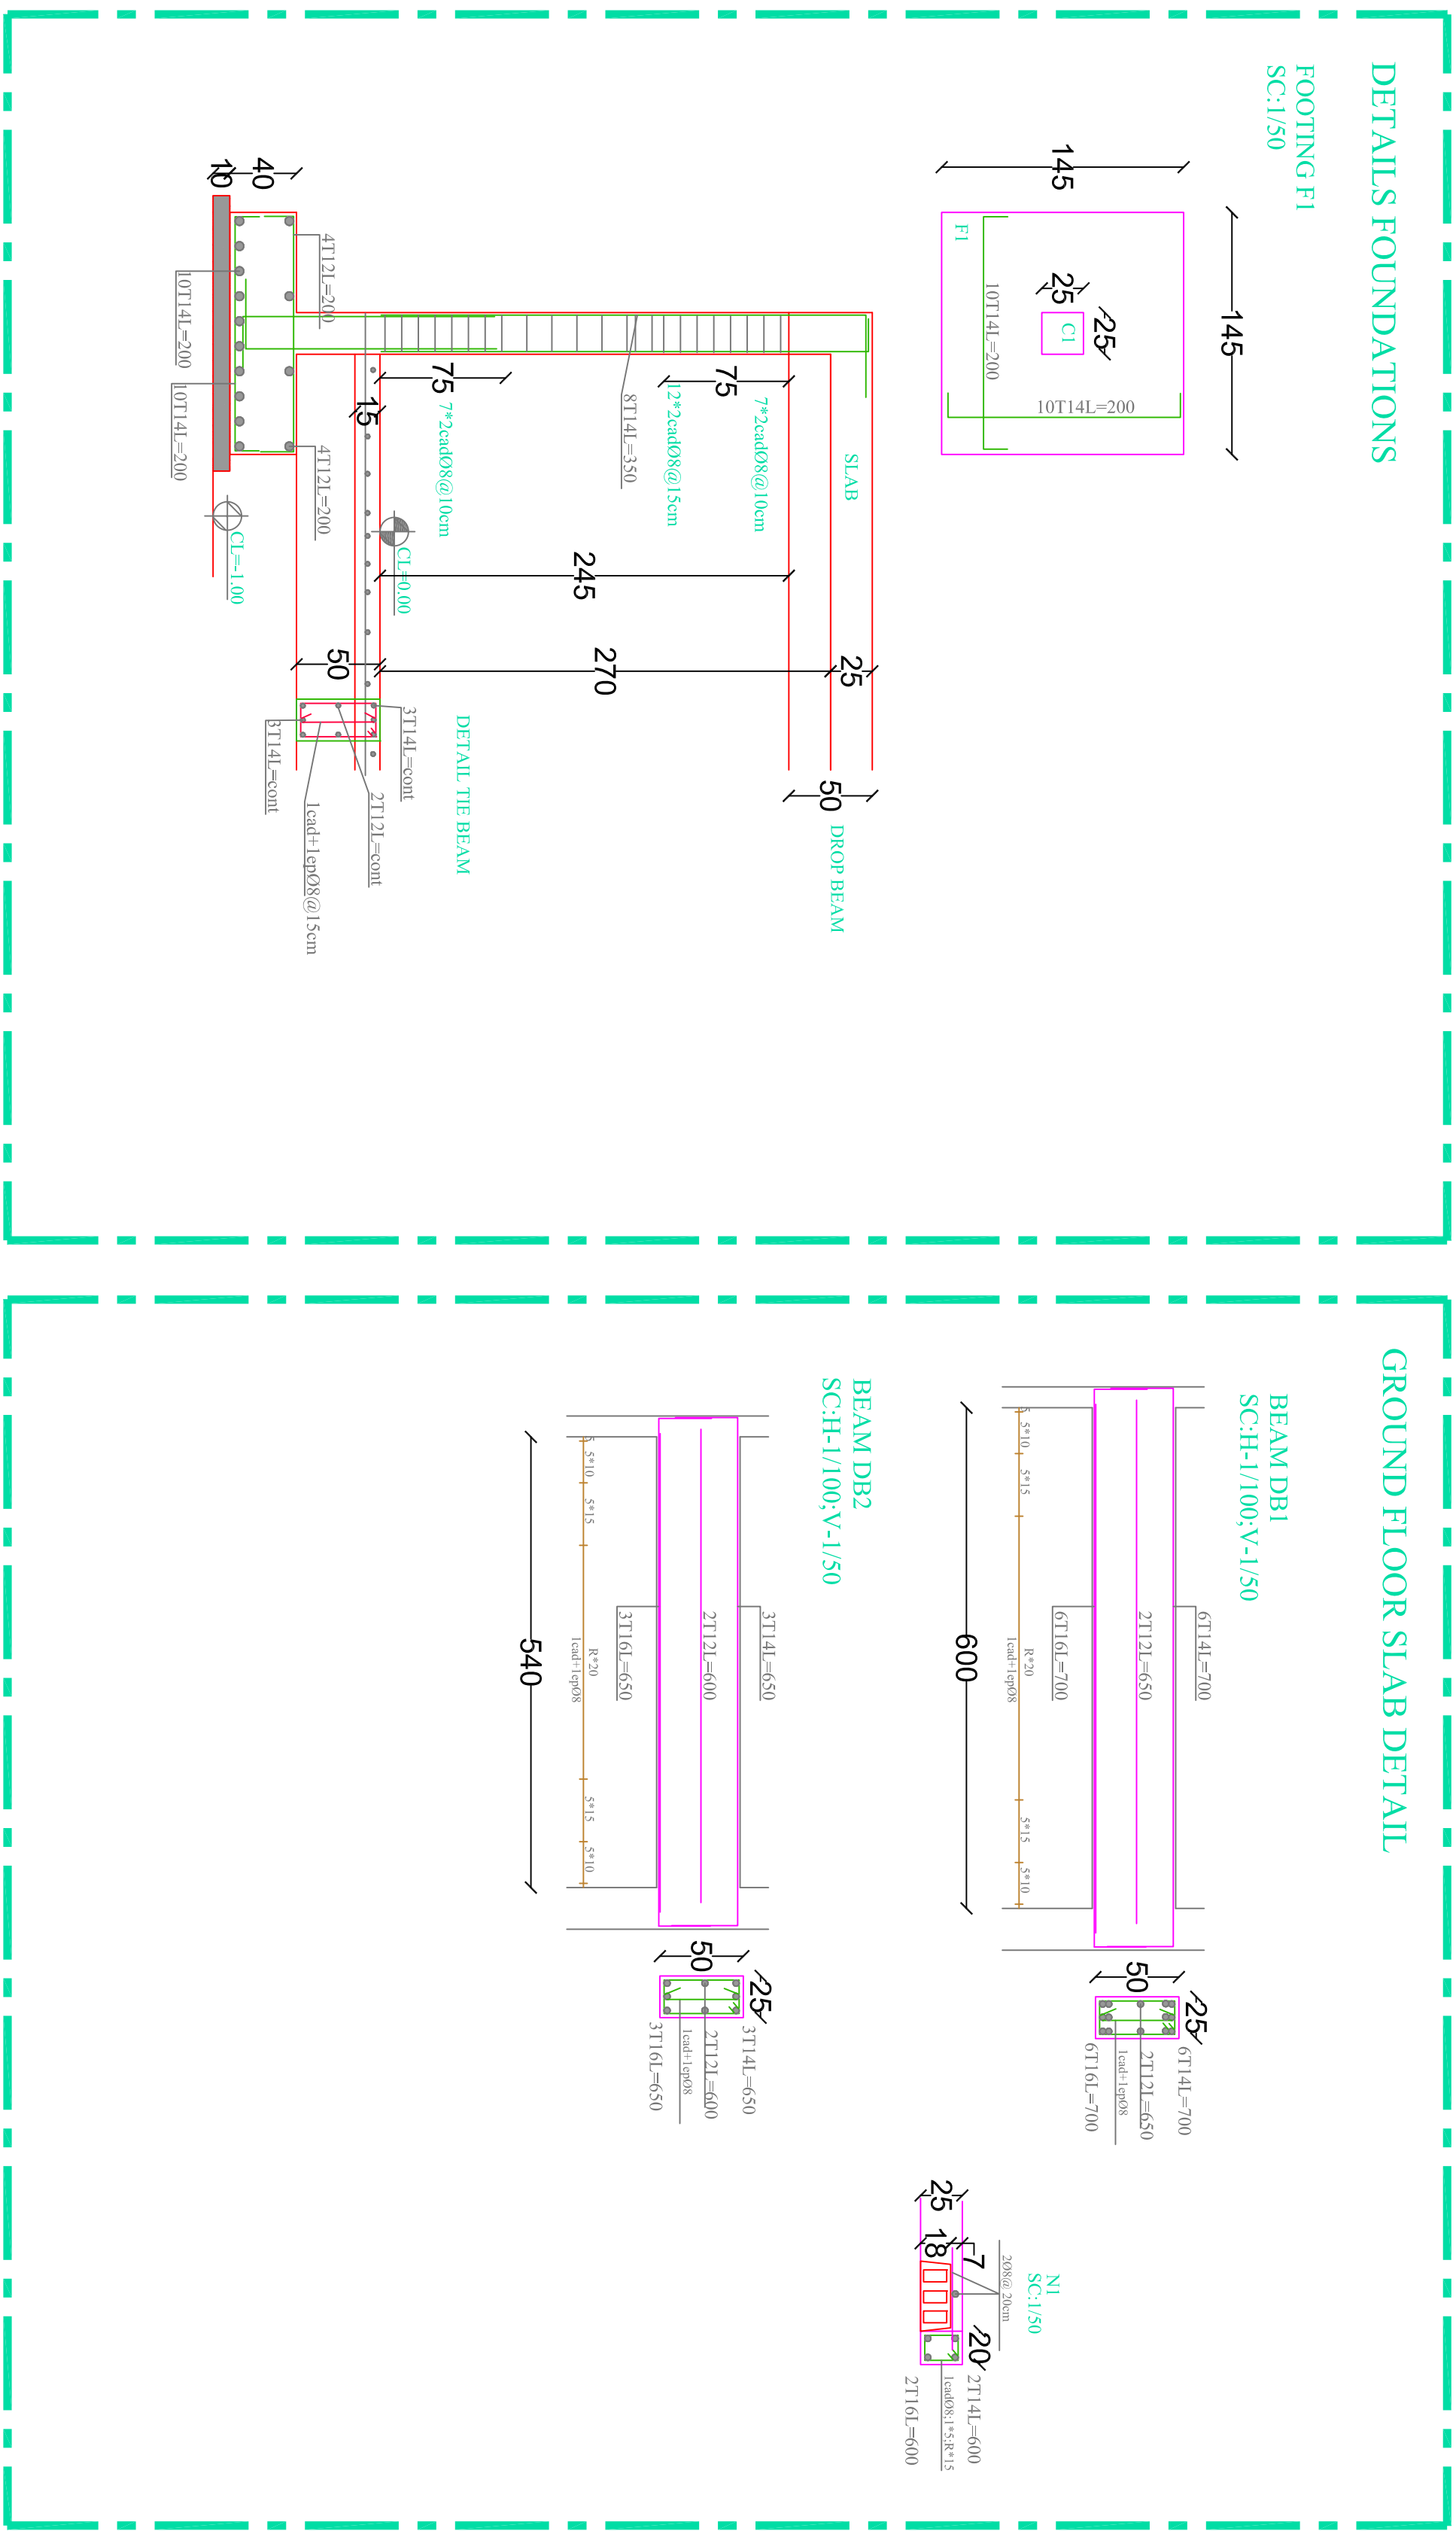

KEY PLAN

THIS DRAWING IS A COPYRIGHT. DO NOT SCALE FROM THE DRAWING.
THE CONTRACTOR AND HIS SUB-CONTRACTORS ARE TO VERIFY ALL DIMENSIONS ON SITE BEFORE MAKING SHOP DRAWINGS OR COMMENCING MANUFACTURE.

United Nation Development Programme
UNDP Lebanon
Social and Local Development Programme
P.O.Box: 11-3216 Beirut, Lebanon
Tel: 961 1 962491


PROGRAMME: Lebanese Host Communities Support Programme
Support to Integrated Service Provision at the Local Level

PROJECT NAME:

PUBLIC GARDEN - CHIAH

NOTES:

THIS DRAWING MUST BE READ IN COMBINATION WITH ALL OTHER ARCHITECTURAL AND ENGINEERING DRAWINGS.
ALL DIMENSIONS ARE IN CM.

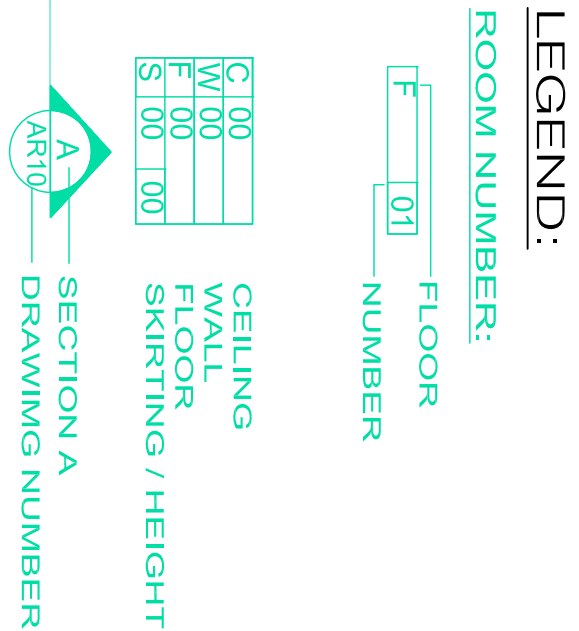

0	---	GENERAL REVISION	---	
REV BY	Date	Description	Appl.	
PROJECT NBR.	---			
DISCIPLINE	ARCHITECTURAL			
SECTOR				
BUILDING				
DESIGNED	M.B.			
DRAWN	M.B.			
CHECKED	---			
APPROVED				
DATE	20-02-2017			
SCALE	1/100			
SHEET SIZE	A1			
Title	ST100			

STRUCTURAL PLAN LAYOUT
BUILDING 1, 2 & 3
FOUNDATION & SLAB DETAILS

PH1-RH-ST100-REV.0

Sheet 1 OF 1

Project Number Phase Type Drawing Number Revision