


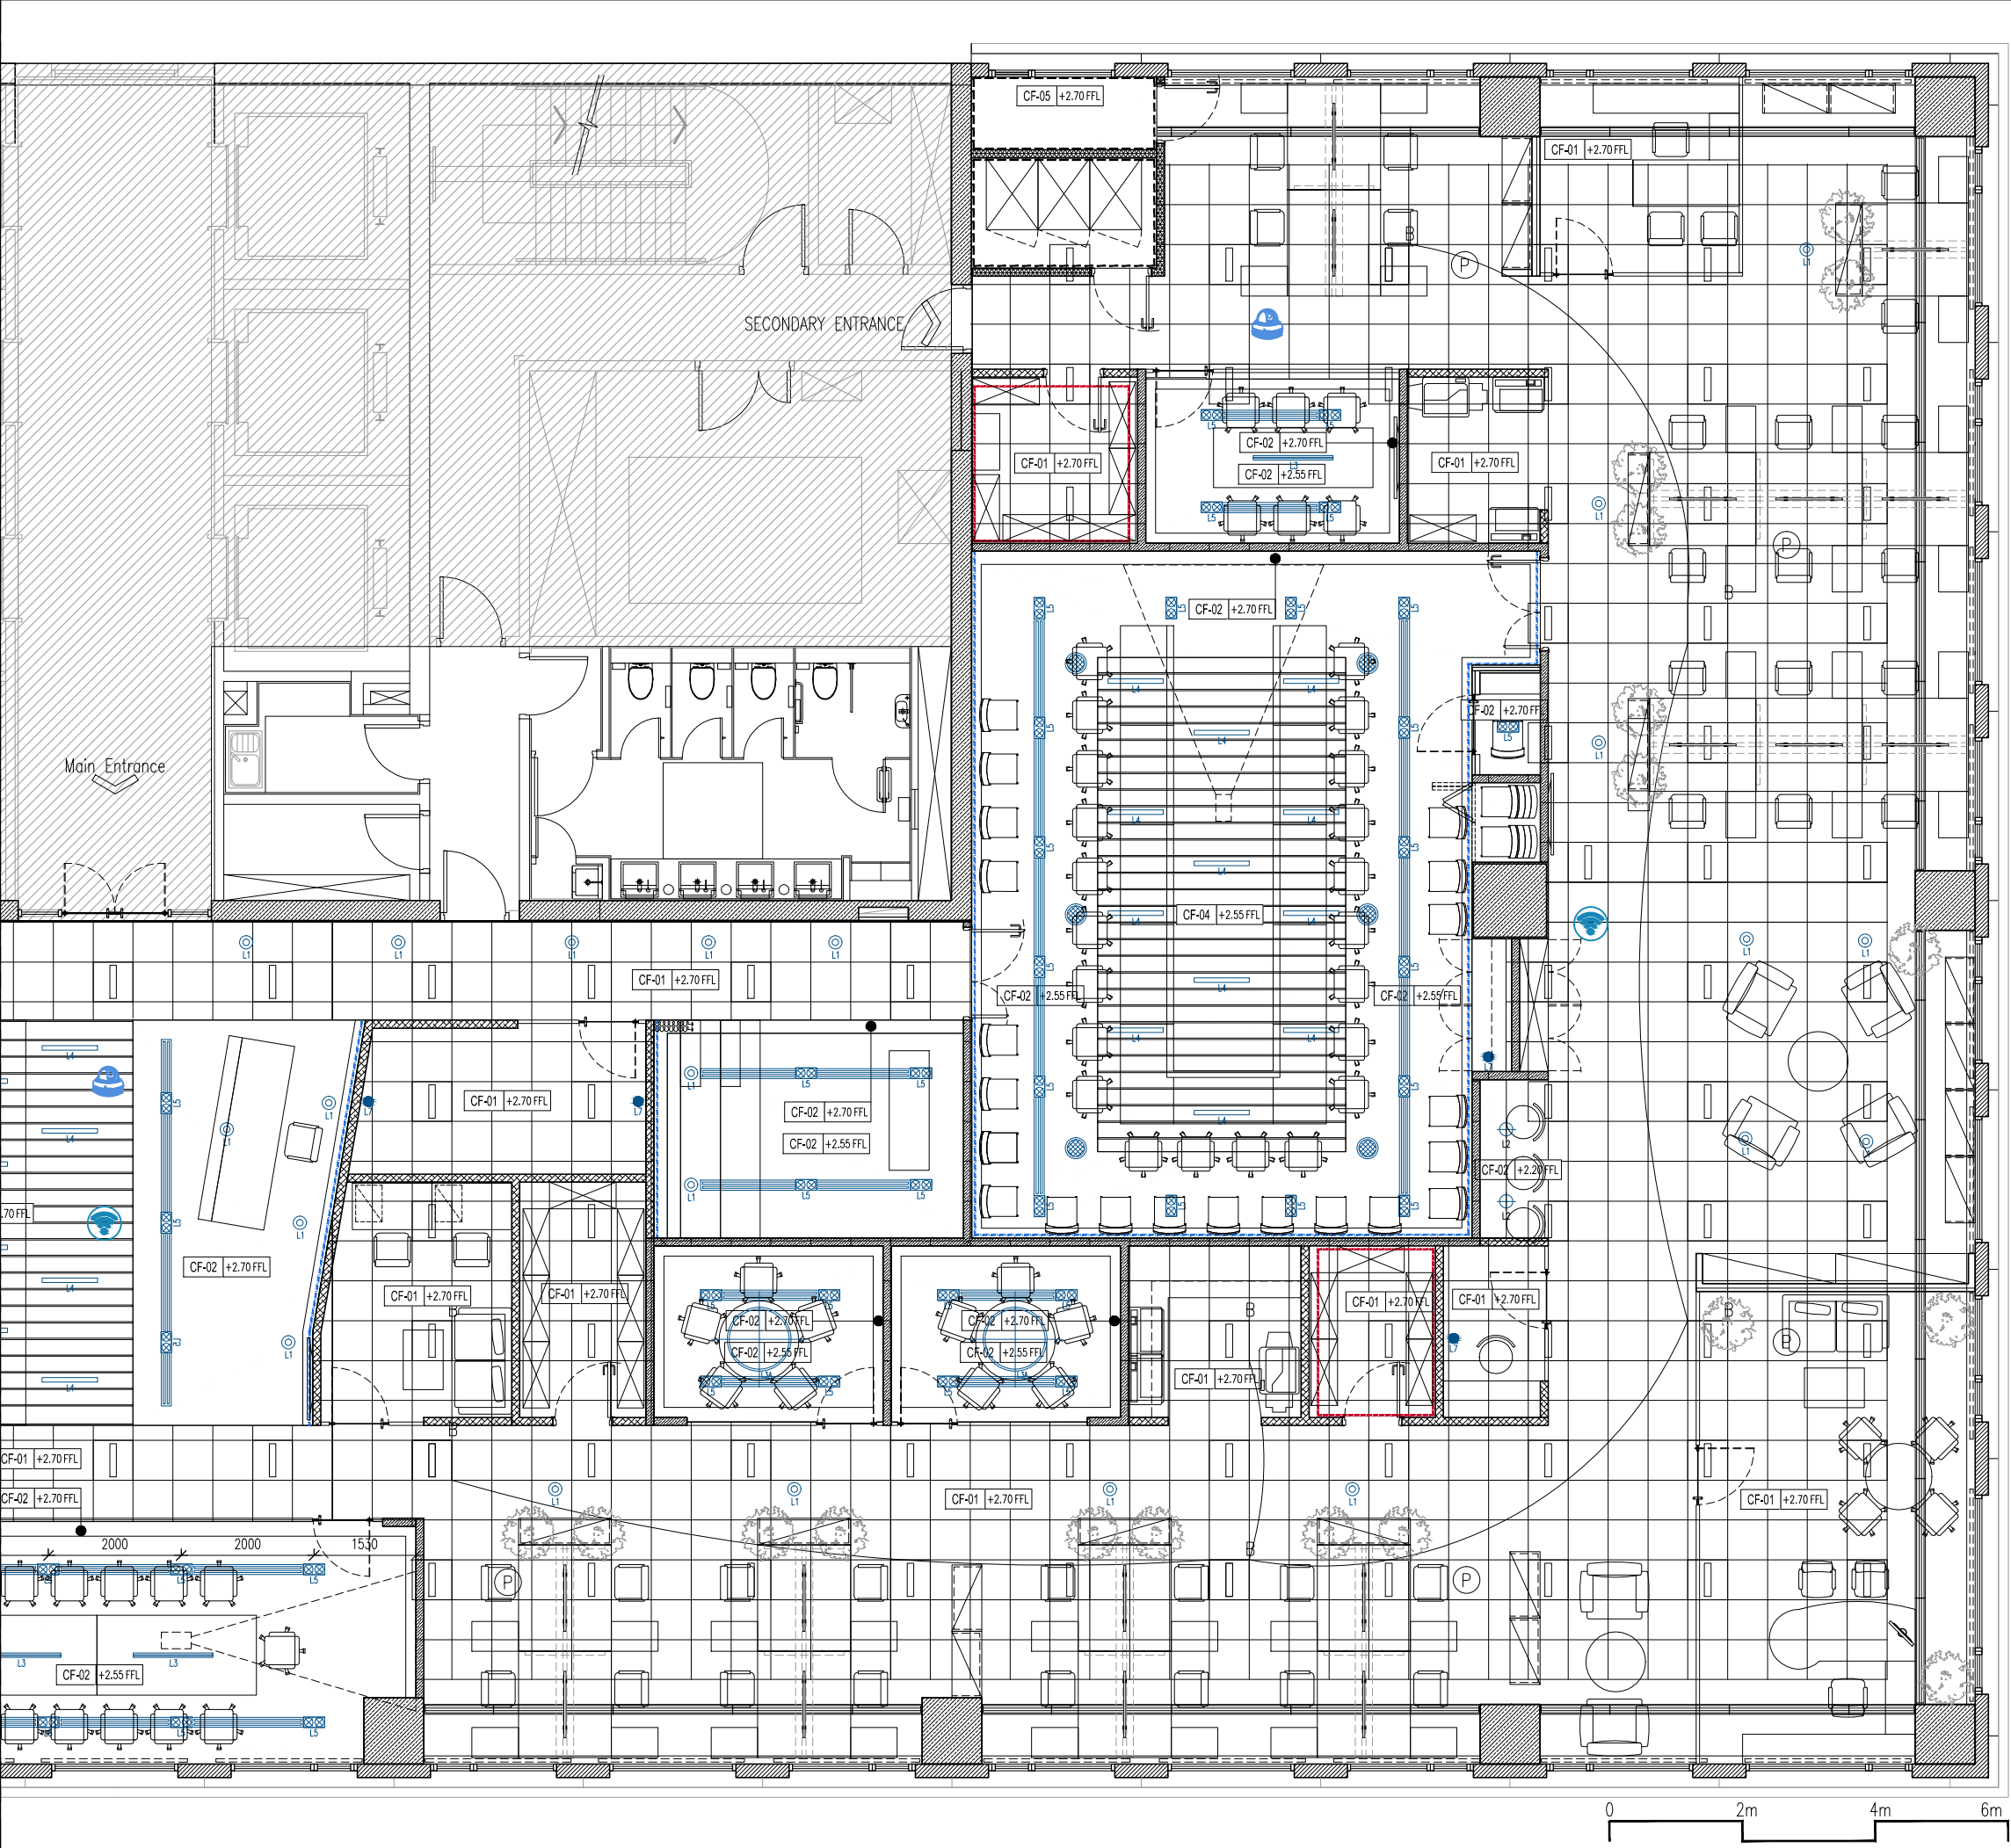

LEGEND : LIGHTING AND ELECTRICAL DEVICE		
SYMBOL	CODE	DESCRIPTION
	L1	SPOT LIGHT
	L2	CEILING MOUNTED LIGHT
	L3	FLUORESCENT PENDANT LIGHT
	L4	RECESSED FLUORESCENT LIGHT
	L5	DOWN LIGHT
	L6	LINEAR LED FIXTURE
	L7	WALL SCONCE FOR PICTURES
		AREAS FOR LIGHTING CONTROLLED BY MOTION SENSOR
		MOUNTED CEILING SPEAKER
		CAMERA
		WIFI
		AIR CONDITIONER
		LINEAR SLOT AIR DIFFUSER FOR AC
		BLIND

LEGEND : CEILING FINISHES	
CODE	DESCRIPTION
CF-01	EXISTING CEILING
CF-01a	EXISTING CEILING PAINTED IN LIGHT GREY
CF-02	WHITE SUSPENDED CEILING
CF-03	LIGHT GREY SUSPENDED CEILING
CF-04	WOOD SLAT CEILING
CF-05	WHITE SUSPENDED CEILING WITH FIRE RATED
REMARK	FL : Finishing level, SL : Structure level FFL : From finishing level

PROJECT OWNER

UNDP

Architecture | Interior Design

Tel: 023 993 620

www.therooms.com

KEY PLAN

Part B

ការព្រមាន:

- មិនត្រូវប្រើប្រាស់ដោយគ្មានការអនុញ្ញាត ឬការអនុវត្តតាមការណែនាំរបស់អ្នករៀបចំ។
- មិនអាចប្រើប្រាស់ដោយគ្មានការអនុញ្ញាត ឬការអនុវត្តតាមការណែនាំរបស់អ្នករៀបចំ។
- មិនអាចប្រើប្រាស់ដោយគ្មានការអនុញ្ញាត ឬការអនុវត្តតាមការណែនាំរបស់អ្នករៀបចំ។

WARNING

- This drawing shall not be used for construction unless certified.
- Contractor to verify all dimensions of existing works on site before commencing any work or preparing shop drawings.
- Do not scale drawings, use written dimensions only.
- All measurements in millimeters.
- All levels in meters.
- This drawing is to be read in conjunction with the specifications and conditions of contract.
- This drawing and design are copyright and no portion may be produced without the permission of The Room Design Studio By Muraya.

REVISIONS:	
H	
G	
F	
E	
D	
C	
B	
A	
REF.	កំណត់សម្គាល់/Remarks
	Date

លេខគម្រោង/Project Title:

UNDP

លេខផែនទី/Drawing Title:

CEILING AND LIGHTING LAYOUT PART B

ស្ថានភាពគម្រោង/Phase:

☒ គម្រោងប្លង់/CONCEPT DESIGN

☐ គម្រោងលម្អិត/DETAILED DESIGN

បុគ្គលិក/POSITION

ឈ្មោះ/NAME

អគ្គនាយក/Director:

P.J

ប្រធានគម្រោង/Project Manager:

P.J

ពិនិត្យ/Checked by:

រៀបចំ/Drawn by:

U.D

ចេញផ្សាយ/Issued for:

ចេញផ្សាយ/Issued Date:

04 MAY 2017

មាត្រដ្ឋាន/Scale:

1/100 (A3)

លេខផែនទី/Drawing No:

257-105b