



*Empowered lives.
Resilient nations.*

**KINGDOM OF SAUDI ARABIA
THE SAUDI FUND FOR DEVELOPMENT (SFD)**

ITB -2017- 171

Drawings

Project name: Reconstruction, Furniture and Equipping of Three Schools

**Photovoltaic Solar System for Holly Family School and the Greek Orthodox
Patriarchate School
PAL10- 00099288**

Funded By :
Kingdom of Saudi Arabia
Through The Saudi Fund For Development (SFD)

Implemented By
United Nations Relief And Works Agency (UNRWA)
Through the United Nations Development Programme (UNDP/PAPP)



*Empowered lives.
Resilient nations.*

**KINGDOM OF SAUDI ARABIA
THE SAUDI FUND FOR DEVELOPMENT (SFD)**

ITB -2017- 171

Lot 01: Photovoltaic Solar System for the Holly Family School

Drawings



Empowered lives.
Resilient nations.



Project name: Reconstruction, Furniture and Equipping of Three Schools

Photovoltaic Solar System for the Holly Family School
PAL10-00099288 - LOT 01

GRAPHIC SCALE				0	1	2	3	4
NO	DATE	ENG	REVISIONS					
PROJECT TITLE								
Reconstruction,Furniture and Equipping of Three Schools								
Photovoltaic Solar System for the Holly Family School (PAL10-00099288)								
CLIENT								
HOLY FAMILY SCHOOL								
FUNDED BY								
			Kingdom of Saudi Arabia					
			Through The Saudi Fund For Development (SFD)					
Implemented By								
			United Nations Relief And Works Agency (UNRWA)					
			United Nations Development Programme (UNDP/PAPP)					
CONSULTANT								
			TECHNICAL ENGINEERING CONSULTING COMPANY					
DRAWING TITLE								
PHOTOVOLTAIC SOLAR DRAWINGS								
PREPARED BY			SCALE			DRAWING NO.		
TECC			1:100			E 00		
CHECKED BY			APPROVED BY			SERIAL NO.		
TECC			UNDP					
DRAWN BY			DATE					
TECC								




GRAPHIC SCALE			0	1	2	3	4
NO	DATE	ENG	REVISIONS				
PROJECT TITLE Reconstruction,Furniture and Equipping of Three Schools Photovoltaic Solar System for the Holy Family School (PAL10-00099288)							
CLIENT HOLY FAMILY SCHOOL							
FUNDED BY  Kingdom of Saudi Arabia  Through The Saudi Fund For Development (SFD)							
Implemented By  United Nations Relief And Works Agency (UNRWA)  United Nations Development Programme (UNDP/PAPF)							
CONSULTANT  TECHNICAL ENGINEERING CONSULTING COMPANY							
DRAWING TITLE Solar System Single line Diagram							
PREPARED BY TECC		SCALE 1:100		DRAWING NO. E 01			
CHECKED BY TECC		APPROVED BY UNDP		SERIAL NO.			
DRAWN BY		DATE					

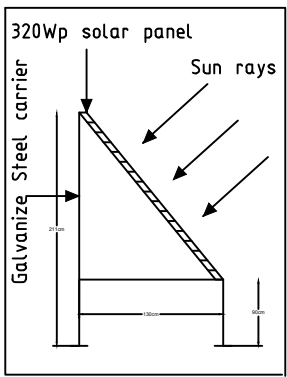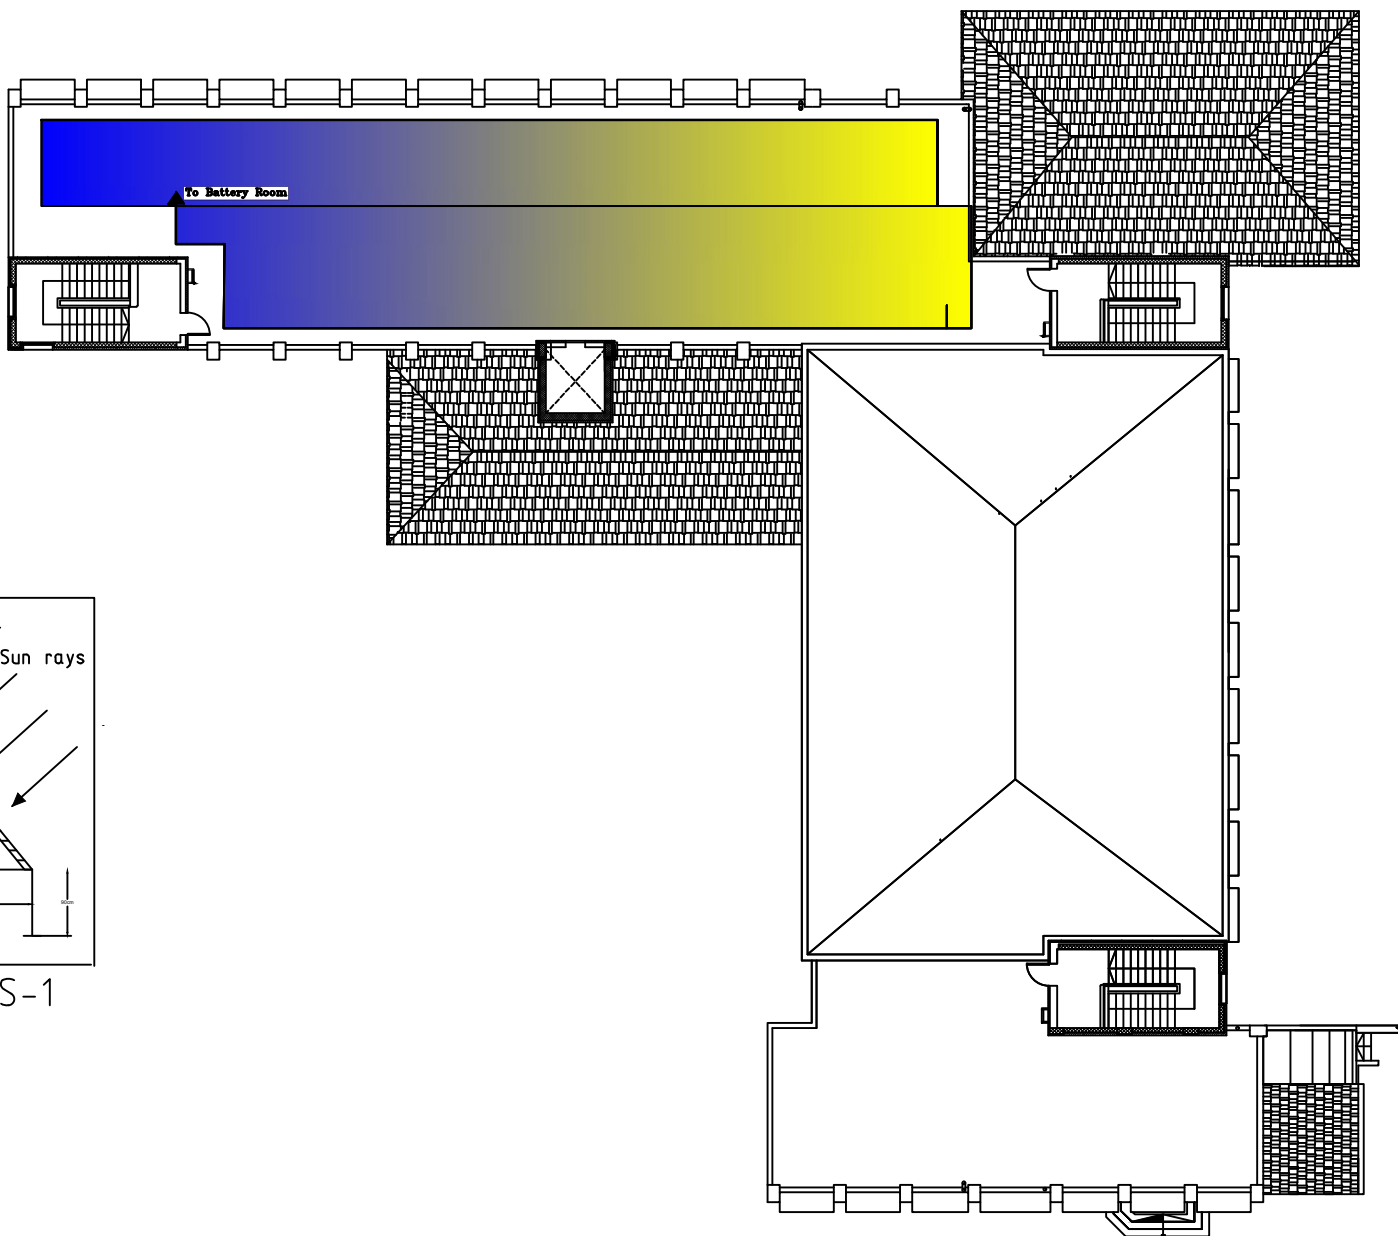

DETAILS-1

PV Cells -Roof Top Layout

GRAPHIC SCALE			0	1	2	3	4
NO	DATE	ENG	REVISIONS				
<u>PROJECT TITLE</u>							
Reconstruction,Furniture and Equipping of Three Schools							
Photovoltaic Solar System for the Holly Family School (PAL10-00099288)							
<u>CLIENT</u>							
HOLY FAMILY SCHOOL							
<u>FUNDED BY</u>							
		Kingdom of Saudi Arabia					
		Through The Saudi Fund For Development (SFD)					
<u>Implemented By</u>							
		United Nations Relief And Works Agency (UNRWA)					
		United Nations Development Programme (UNDP/PAPP)					
<u>CONSULTANT</u>							
		TECHNICAL ENGINEERING CONSULTING COMPANY					
<u>DRAWING TITLE</u>							
PV Cells -Roof Top Layout							
PREPARED BY		SCALE		DRAWING NO.			
TECC		1:100		E 02			
CHECKED BY		APPROVED BY		SERIAL NO.			
TECC		UNDP					
DRAWN BY		DATE					
TECC							

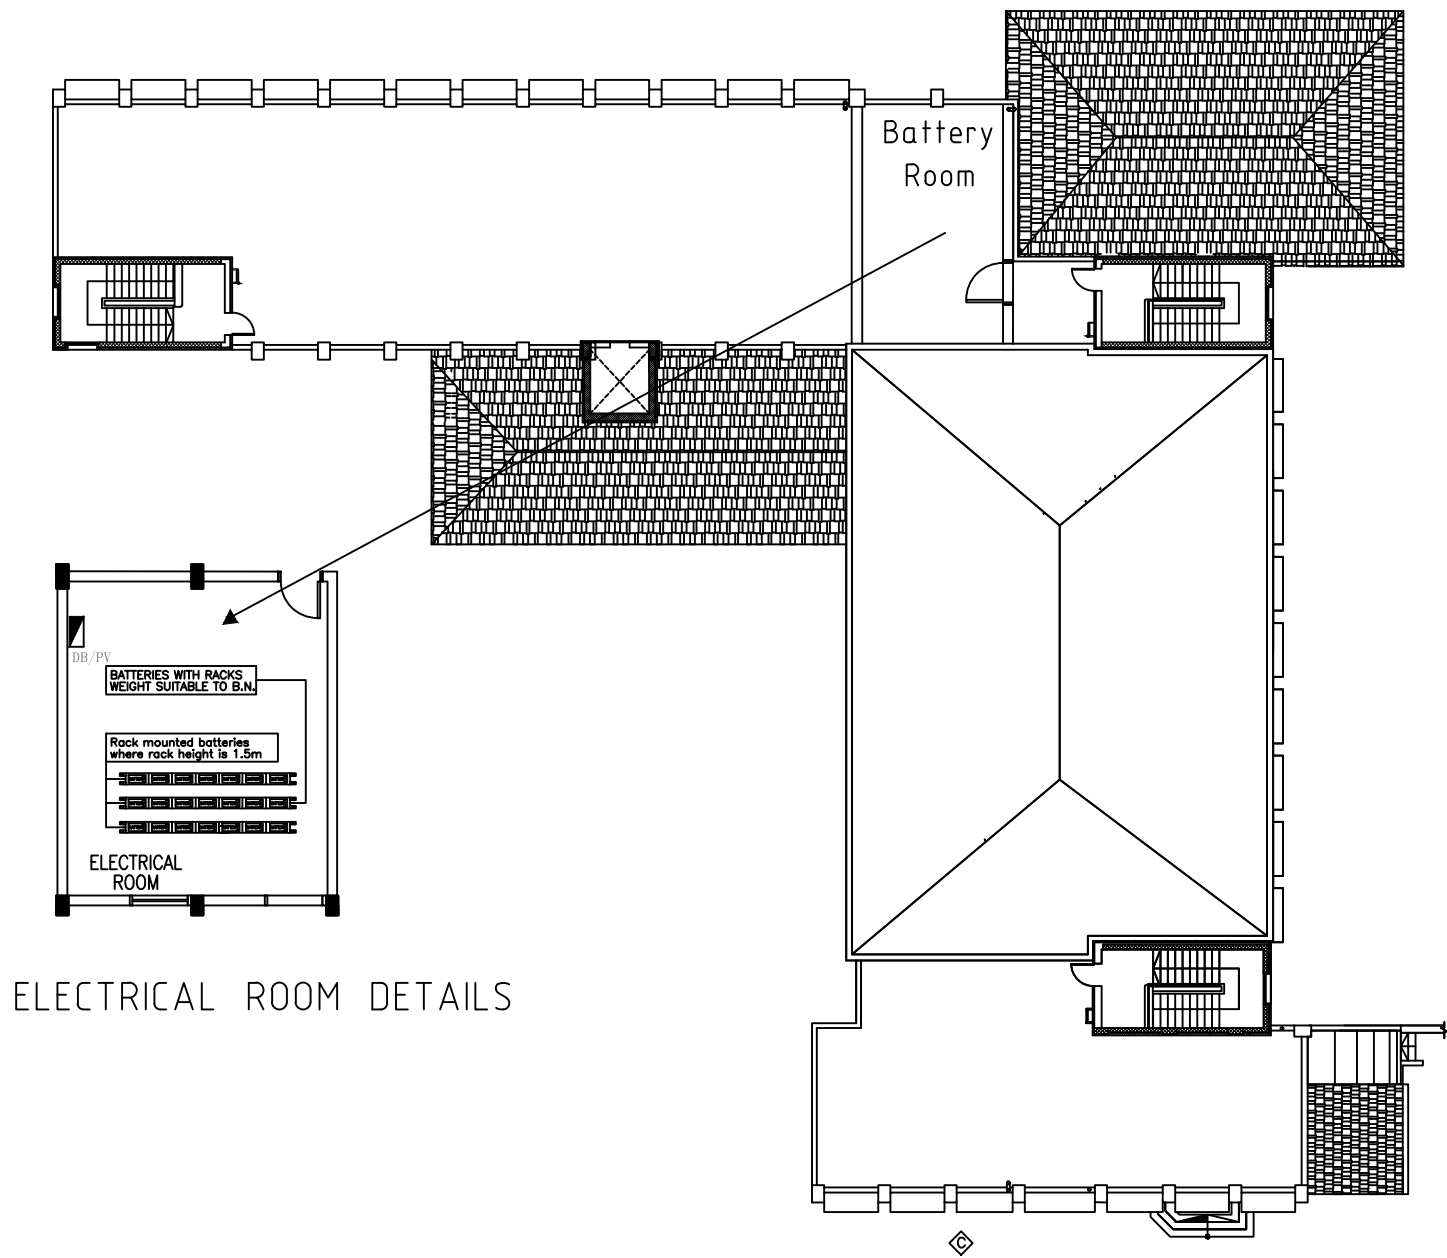

ELECTRICAL ROOM DETAILS

Battery Room Layout

GRAPHIC SCALE 0 1 2 3 4

NO	DATE	ENG	REVISIONS

PROJECT TITLE
Reconstruction, Furniture and
Equipping of Three Schools
Photovoltaic Solar System for the
Holly Family School
(PAL10-00099288)

CLIENT
HOLY FAMILY SCHOOL


FUNDED BY
 Kingdom of Saudi Arabia
Through The Saudi Fund
For Development (SFD)

Implemented By
 United Nations Relief And
Works Agency (UNRWA)
 United Nations Development
Programme (UNDP/PAPP)

CONSULTANT
 TECHNICAL ENGINEERING
CONSULTING COMPANY

DRAWING TITLE
Battery Room Layout

PREPARED BY TECC	SCALE 1:100	DRAWING NO. E 03
CHECKED BY TECC	APPROVED BY UNDP	SERIAL NO.
DRAWN BY TECC	DATE	

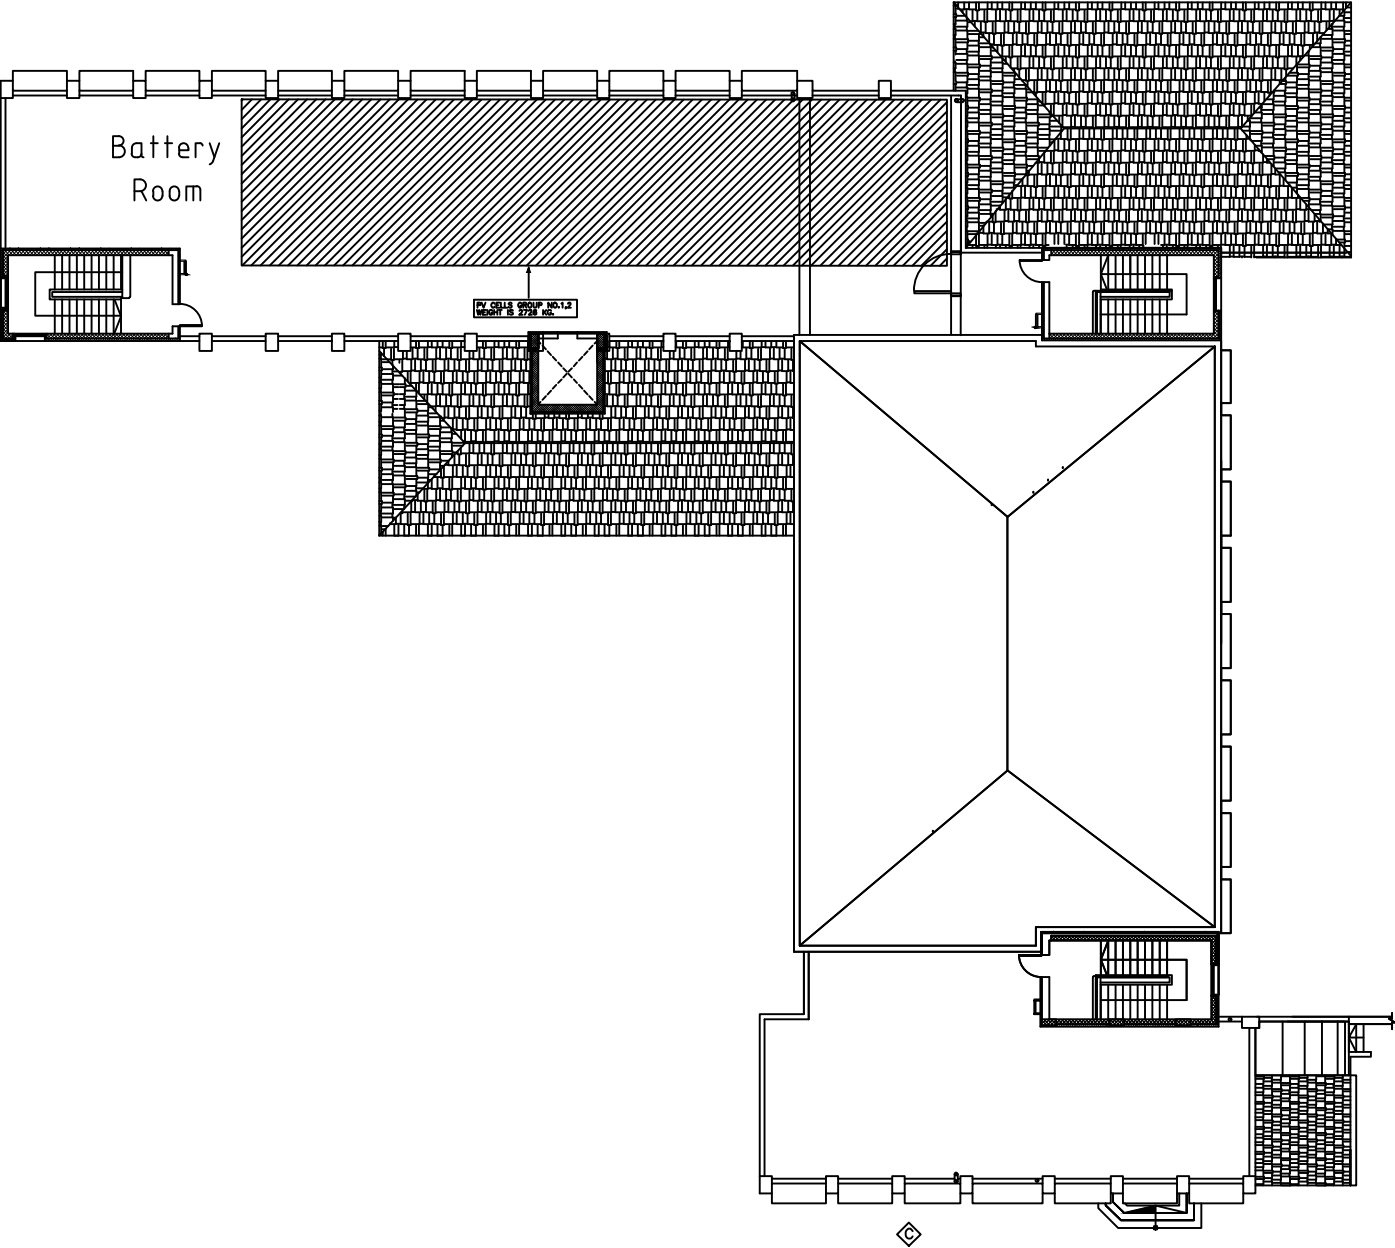

Weights of PV solar System Equipment

GRAPHIC SCALE							
NO	DATE	ENG	REVISIONS				
PROJECT TITLE							
Reconstruction,Furniture and Equipping of Three Schools							
Photovoltaic Solar System for the Holly Family School (PAL10-00099288)							
CLIENT							
HOLY FAMILY SCHOOL							
FUNDED BY							
			Kingdom of Saudi Arabia Through The Saudi Fund For Development (SFD)				
Implemented By							
			United Nations Relief And Works Agency (UNRWA)				
			United Nations Development Programme (UNDP/PAPP)				
CONSULTANT							
			TECHNICAL ENGINEERING CONSULTING COMPANY				
DRAWING TITLE							
Weights of PV solar System Equipment							
PREPARED BY TECC		SCALE 1:100		DRAWING NO. E 04			
CHECKED BY TECC		APPROVED BY UNDP					
DRAWN BY TECC		DATE		SERIAL NO.			



HOLY FAMILY SCHOOL
ELECTRICAL DRAWINGS

GRAPHIC SCALE 0 1 2 3 4

NO	DATE	ENG	REVISIONS

PROJECT TITLE
Reconstruction,Furniture and
Equipping of Three Schools
Photovoltaic Solar System for the
Holly Family School
(PAL10-00099288)

CLIENT
HOLY FAMILY SCHOOL


FUNDED BY
 Kingdom of Saudi Arabia
 Through The Saudi Fund
For Development (SFD)

Implemented By
 United Nations Relief And
Works Agency (UNRWA)
 United Nations Development
Programme (UNDP/PAPP)


CONSULTANT
 TECHNICAL ENGINEERING
CONSULTING COMPANY

DRAWING TITLE
ELECTRICAL DRAWING


PREPARED BY	SCALE	DRAWING NO.
TECC	1:100	E 05
CHECKED BY	APPROVED BY	SERIAL NO.
TECC	UNDP	
DRAWN BY	DATE	
TECC		

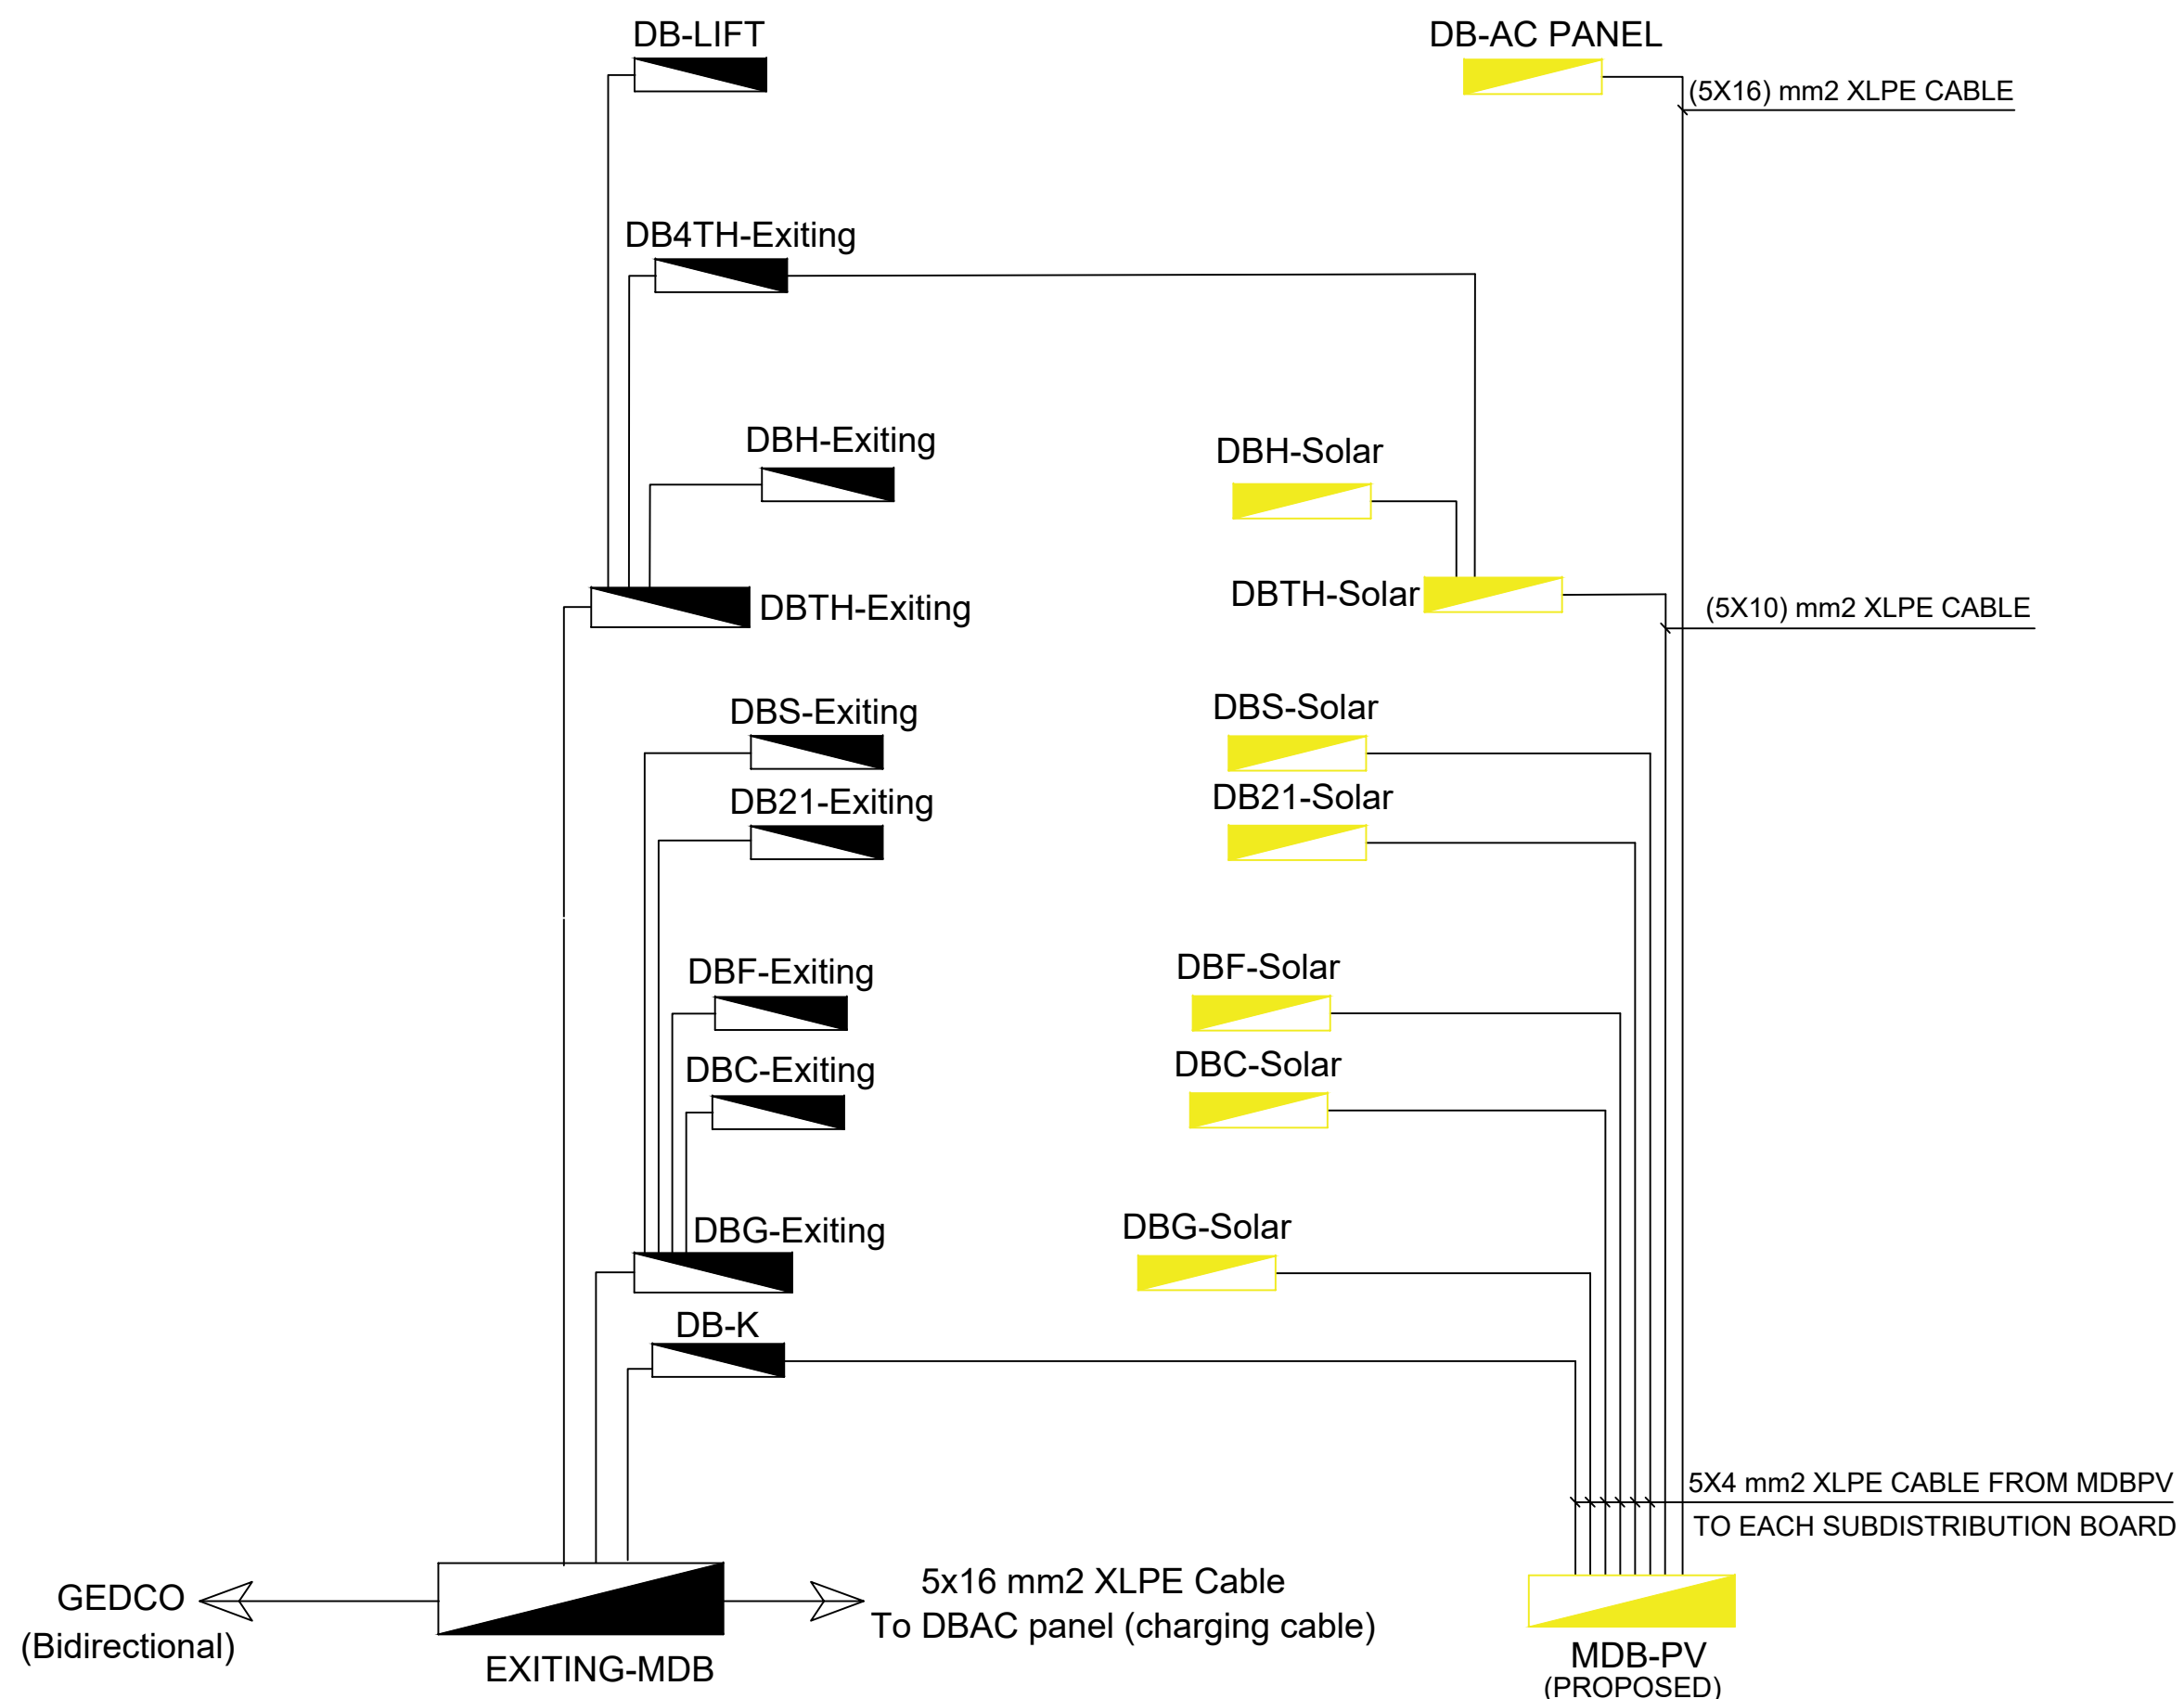


GRAPHIC SCALE 0 1 2 3 4			
NO	DATE	ENG	REVISIONS
PROJECT TITLE			
Reconstruction, Furniture and Equipping of Three Schools			
Photovoltaic Solar System for the Holly Family School (PAL10-00099288)			
CLIENT			
HOLY FAMILY SCHOOL			
FUNDED BY			
 Kingdom of Saudi Arabia Through The Saudi Fund For Development (SFD)			
Implemented By			
 United Nations Relief And Works Agency (UNRWA)			
 United Nations Development Programme (UNDP/PAPP)			
CONSULTANT			
 TECHNICAL ENGINEERING CONSULTING COMPANY			
DRAWING TITLE			
POWER RISER DIAGRAM			
PREPARED BY	SCALE	DRAWING NO.	
TECC	1:100	E 06	
CHECKED BY	APPROVED BY	SERIAL NO.	
TECC	UNDP		
DRAWN BY	DATE		
TECC			

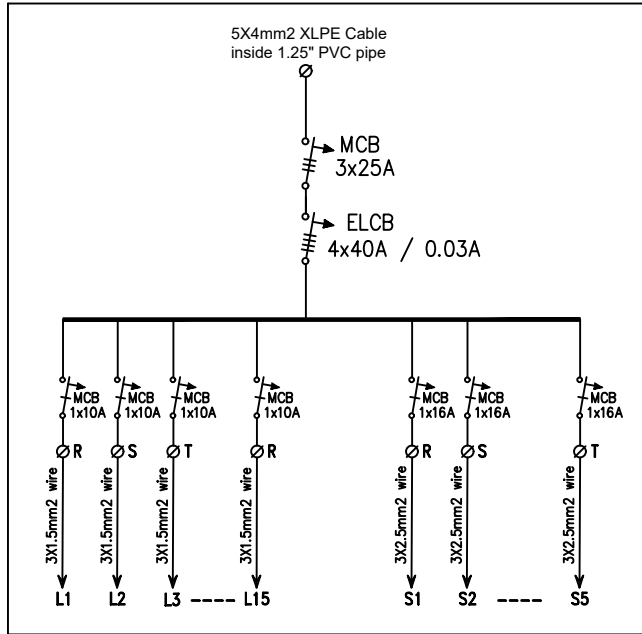


SUB-DISTRIBUTION BOARD DBG-SOLAR
IN GROUND FLOOR

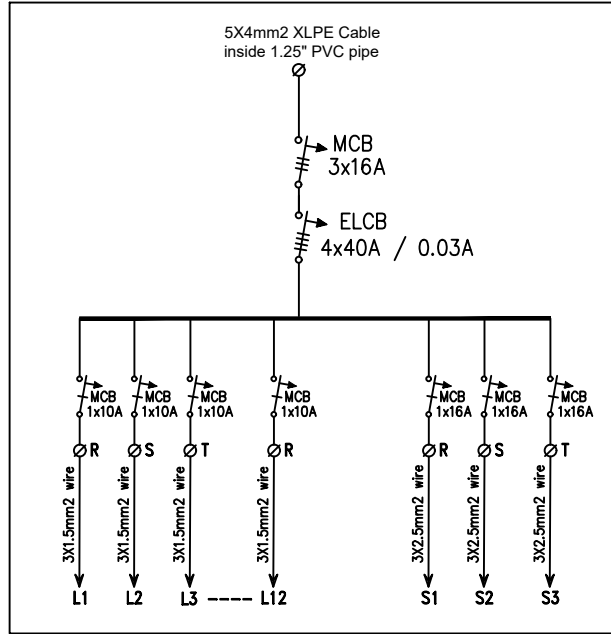


SUB-DISTRIBUTION BOARD DBF-SOLAR
IN FIRST FLOOR

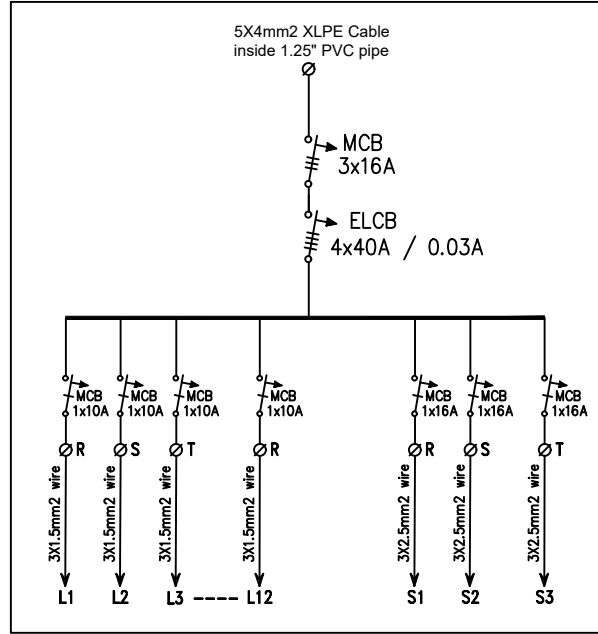


SUB-DISTRIBUTION BOARD DBS-SOLAR
IN SECOND FLOOR

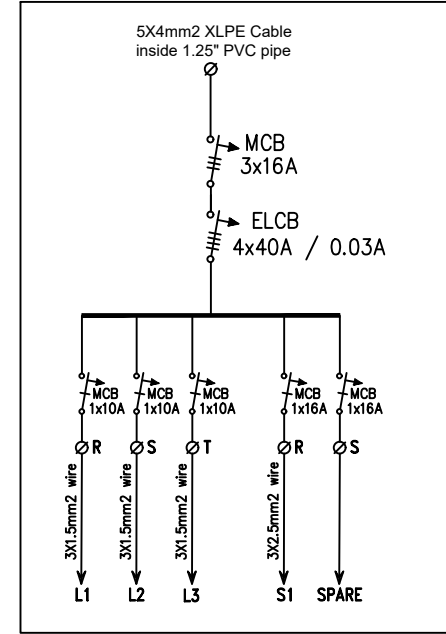


SUB-DISTRIBUTION BOARD DB21-SOLAR
IN SECOND FLOOR

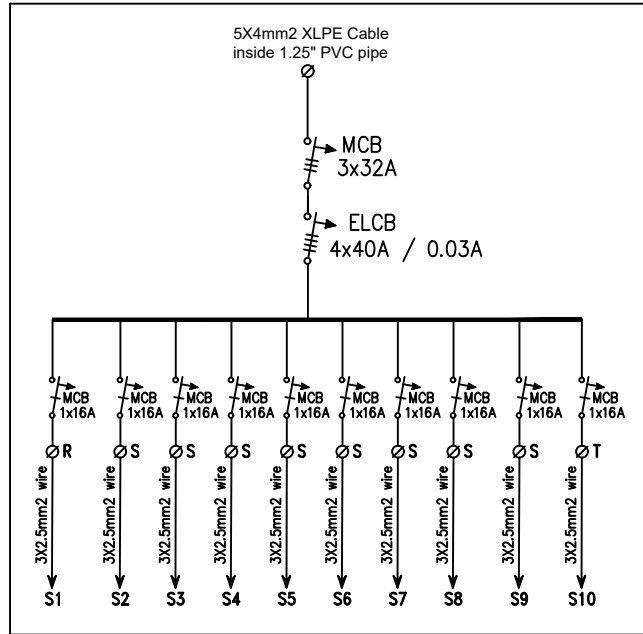

SUB-DISTRIBUTION BOARD DBC-SOLAR
COMPUTER LAB.

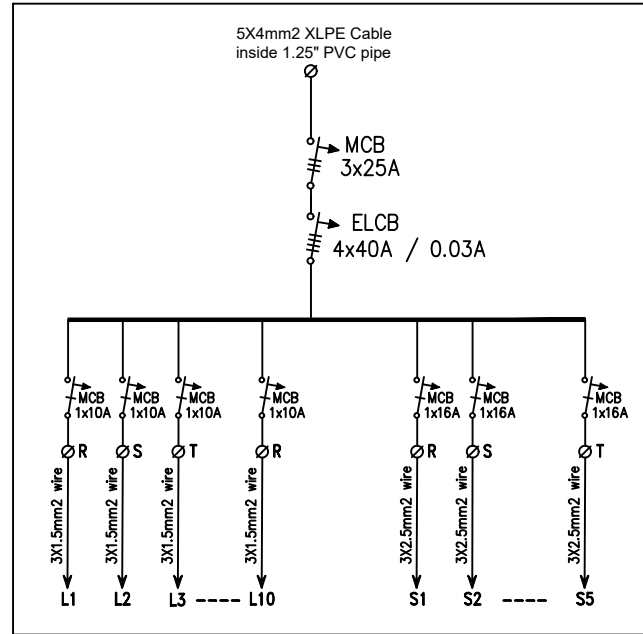


SUB-DISTRIBUTION BOARD DBH-SOLAR
HALL IN THIRD FLOOR

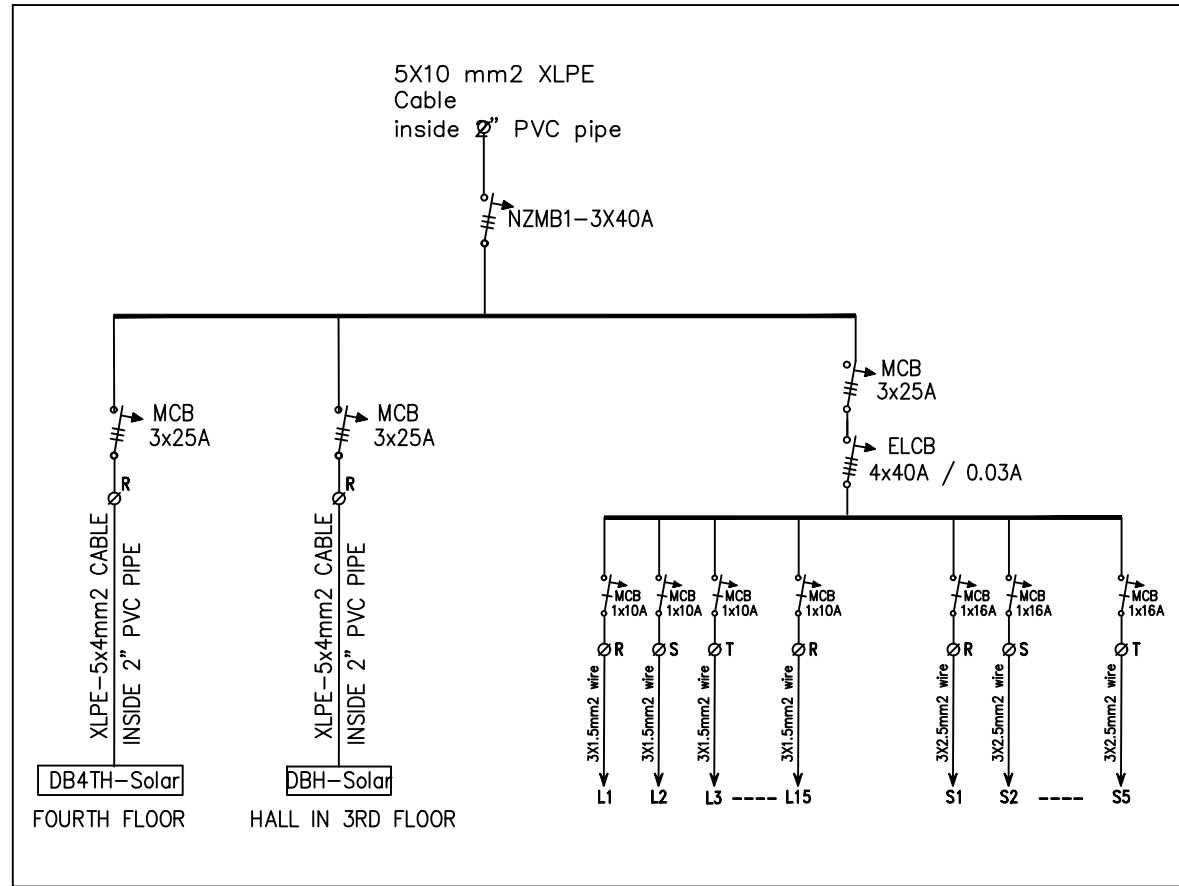

SUB-DISTRIBUTION BOARD DBTH-SOLAR
IN THIRD FLOOR

GRAPHIC SCALE			
0	1	2	3
4	5	6	7
8	9	10	11
1116	1117	1118	1119

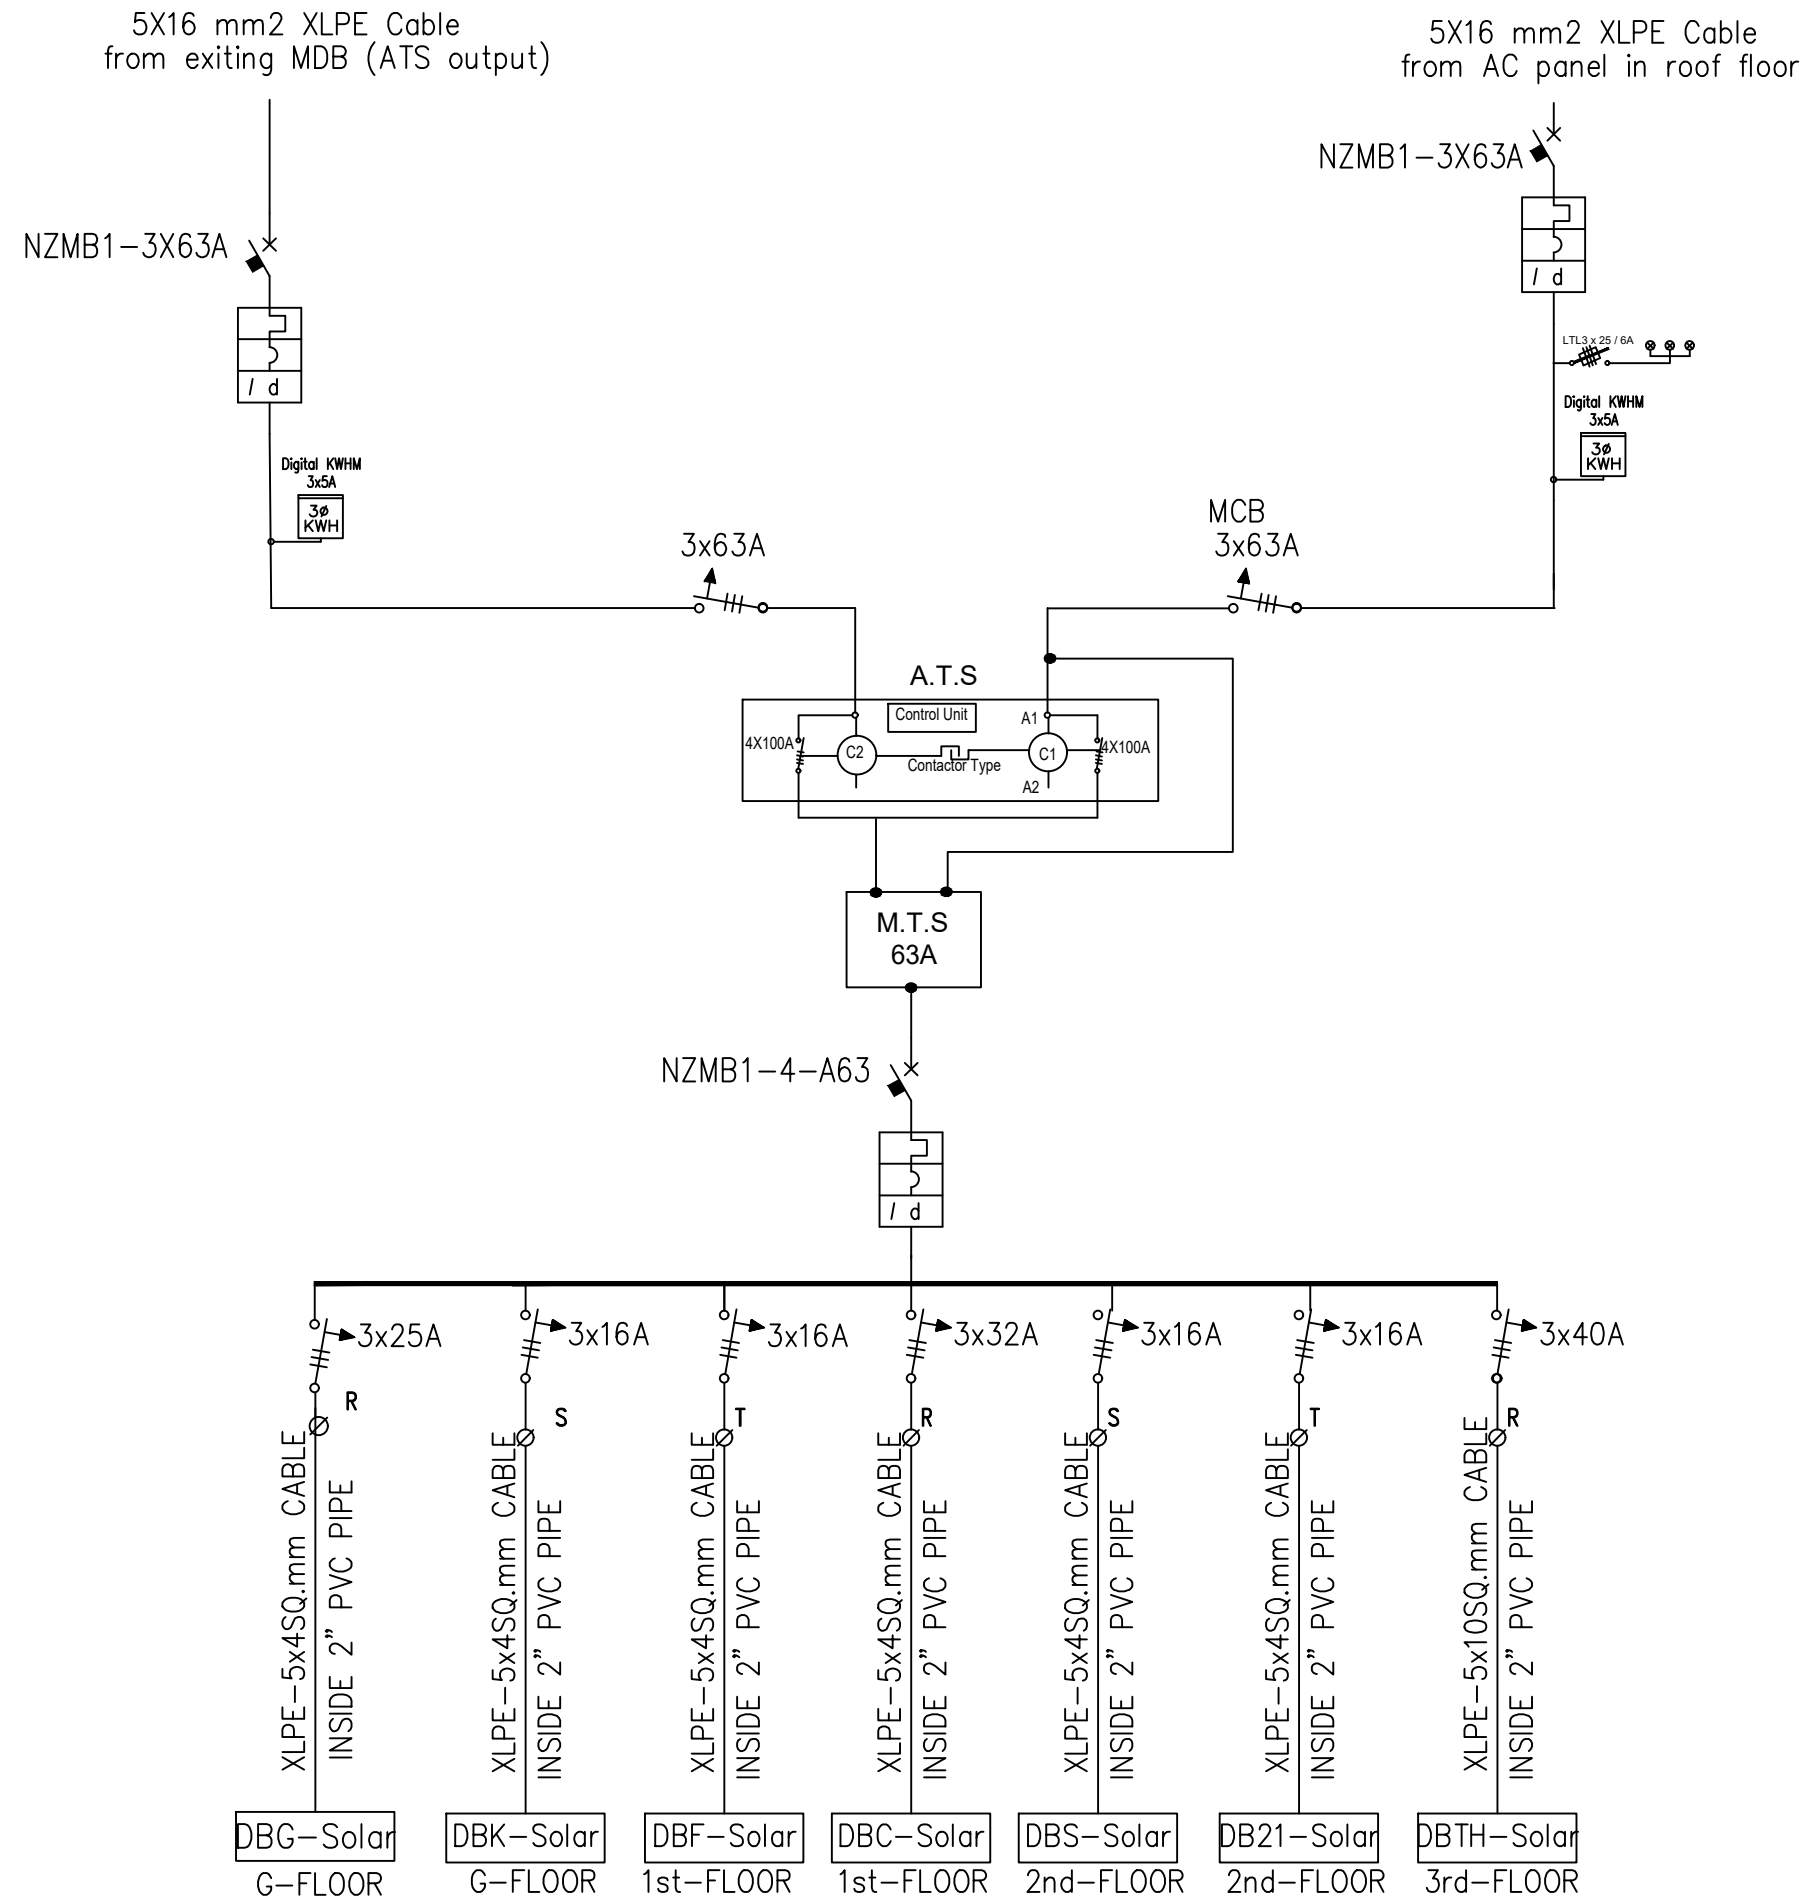

GRAPHIC SCALE			
0	1	2	3
4			
NO	DATE	ENG	REVISIONS

PROJECT TITLE
Reconstruction, Furniture and
Equipping of Three Schools
Photovoltaic Solar System for the
Holly Family School
(PAL10-00099288)

CLIENT
HOLY FAMILY SCHOOL





FUNDED BY
 Kingdom of Saudi Arabia
Through The Saudi Fund
For Development (SFD)

Implemented By
 United Nations Relief And
Works Agency (UNRWA)
 United Nations Development
Programme (UNDP/PAPP)

CONSULTANT
 TECHNICAL ENGINEERING
CONSULTING COMPANY

DRAWING TITLE
SOLAR DISTRIBUTION BOARD

PREPARED BY TECC	SCALE 1:100	DRAWING NO. E 08
CHECKED BY TECC	APPROVED BY UNDP	SERIAL NO.
DRAWN BY TECC	DATE	

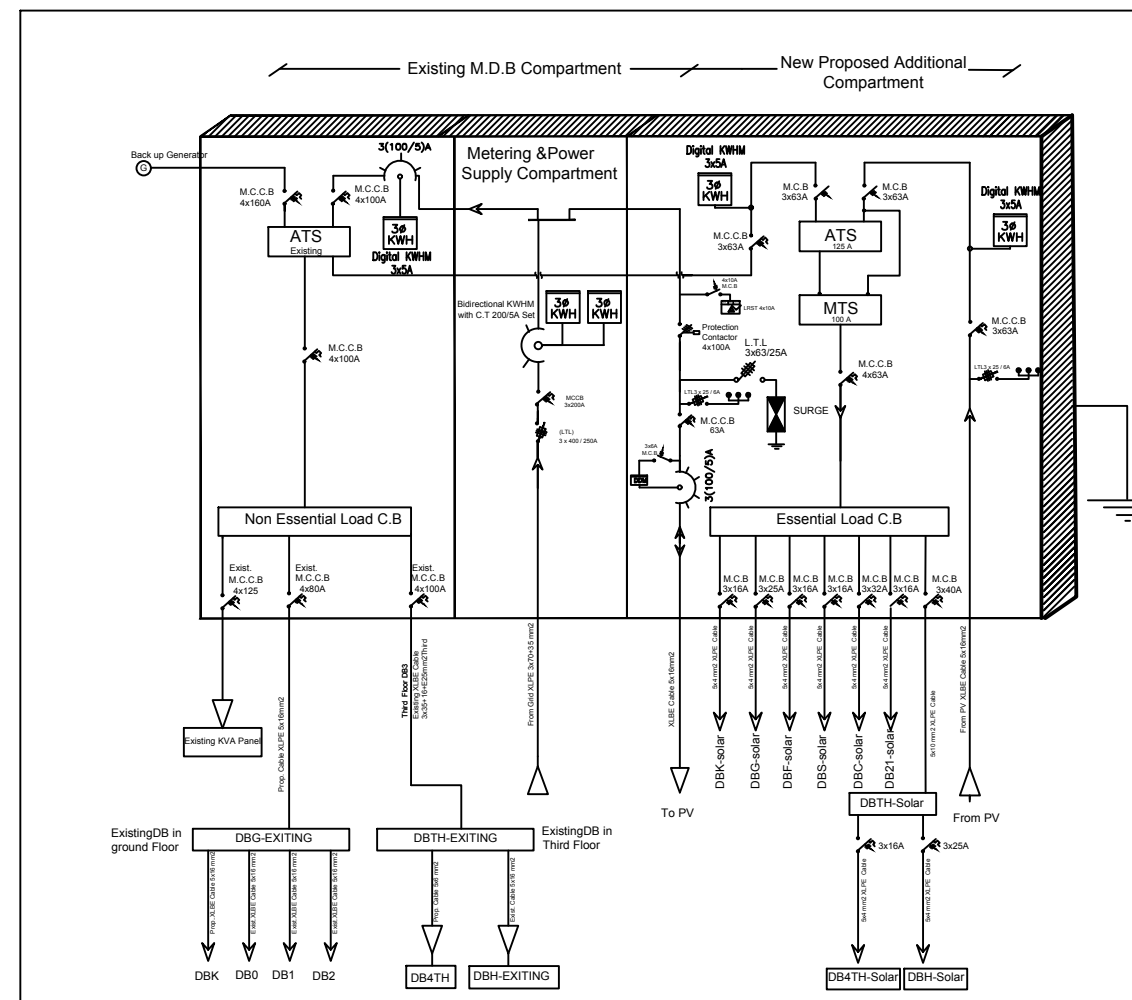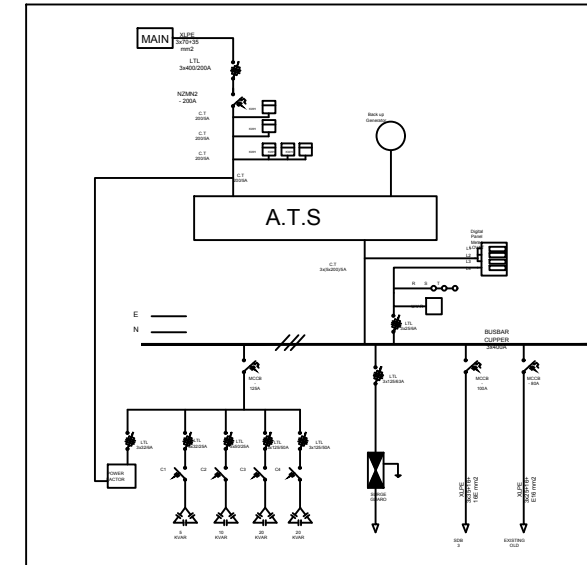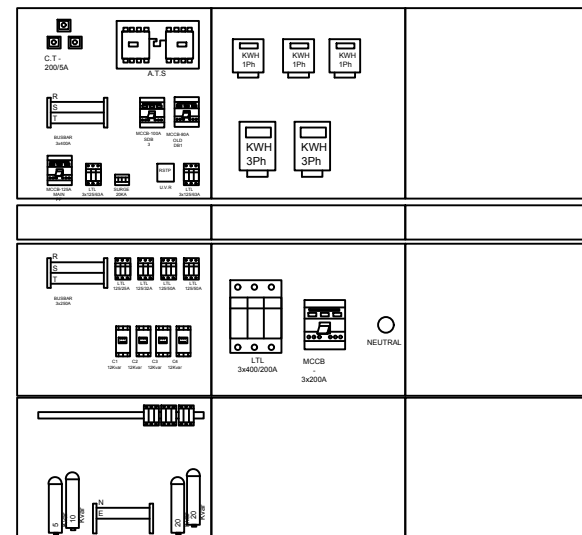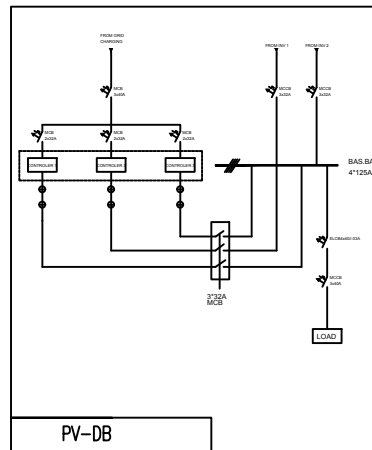

MODIFIED MAIN DISTRIBUTION BOARD

GRAPHIC SCALE			
NO	DATE	ENG	REVISIONS

NO	DATE	ENG	REVISIONS
----	------	-----	-----------

PROJECT TITLE

**Reconstruction, Furniture and
Equipping of Three Schools**

**Photovoltaic Solar System for the
Holly Family School**

(PAL10-00099288)

CLIENT

HOLY FAMILY SCHOOL

FUNDED BY



Implemented By



CONSULTANT



<u>DRAWING TITLE</u>
MODIFIED MAIN DISTRIBUTION BOARD

PREPARED BY TECC	SCALE 1:100	DRAWING NO. E 09
CHECKED BY TECC	APPROVED BY UNDP	
DRAWN BY TECC	DATE	
		SERIAL NO.



*Empowered lives.
Resilient nations.*

**KINGDOM OF SAUDI ARABIA
THE SAUDI FUND FOR DEVELOPMENT (SFD)**

ITB -2017- 171

Lot 02: Photovoltaic Solar System for the Greek Orthodox Patriarchate School

Drawings




Project name: Reconstruction, Furniture and Equipping of Three Schools

Photovoltaic Solar System for the Greek Orthodox Patriarchate School
PAL10- 00099288

2017

GRAPHIC SCALE		
0 1 2 3 4		
NO	DATE	ENG
REVISIONS		
PROJECT TITLE		
Reconstruction,Furniture and Equipping of Three Schools		
Photovoltaic Solar System for the Greek Orthodox Patriarchate School (PAL10-00099288)		
CLIENT		
Greek Orthodox Patriarchate School		
FUNDED BY		
	Kingdom of Saudi Arabia Through The Saudi Fund For Development (SFD)	
Implemented By		
	United Nations Relief And Works Agency (UNRWA)	
	United Nations Development Programme (UNDP/PAPP)	
CONSULTANT		
	TECHNICAL ENGINEERING CONSULTING COMPANY	
DRAWING TITLE		
DRAWING TITLE :		
PREPARED BY	SCALE	DRAWING NO.
TECC	1:100	E00
CHECKED BY	APPROVED BY	SERIAL NO.
TECC	UNDP	
DRAWN BY	DATE	
TECC	August 2016	

Solar System Single line Diagram

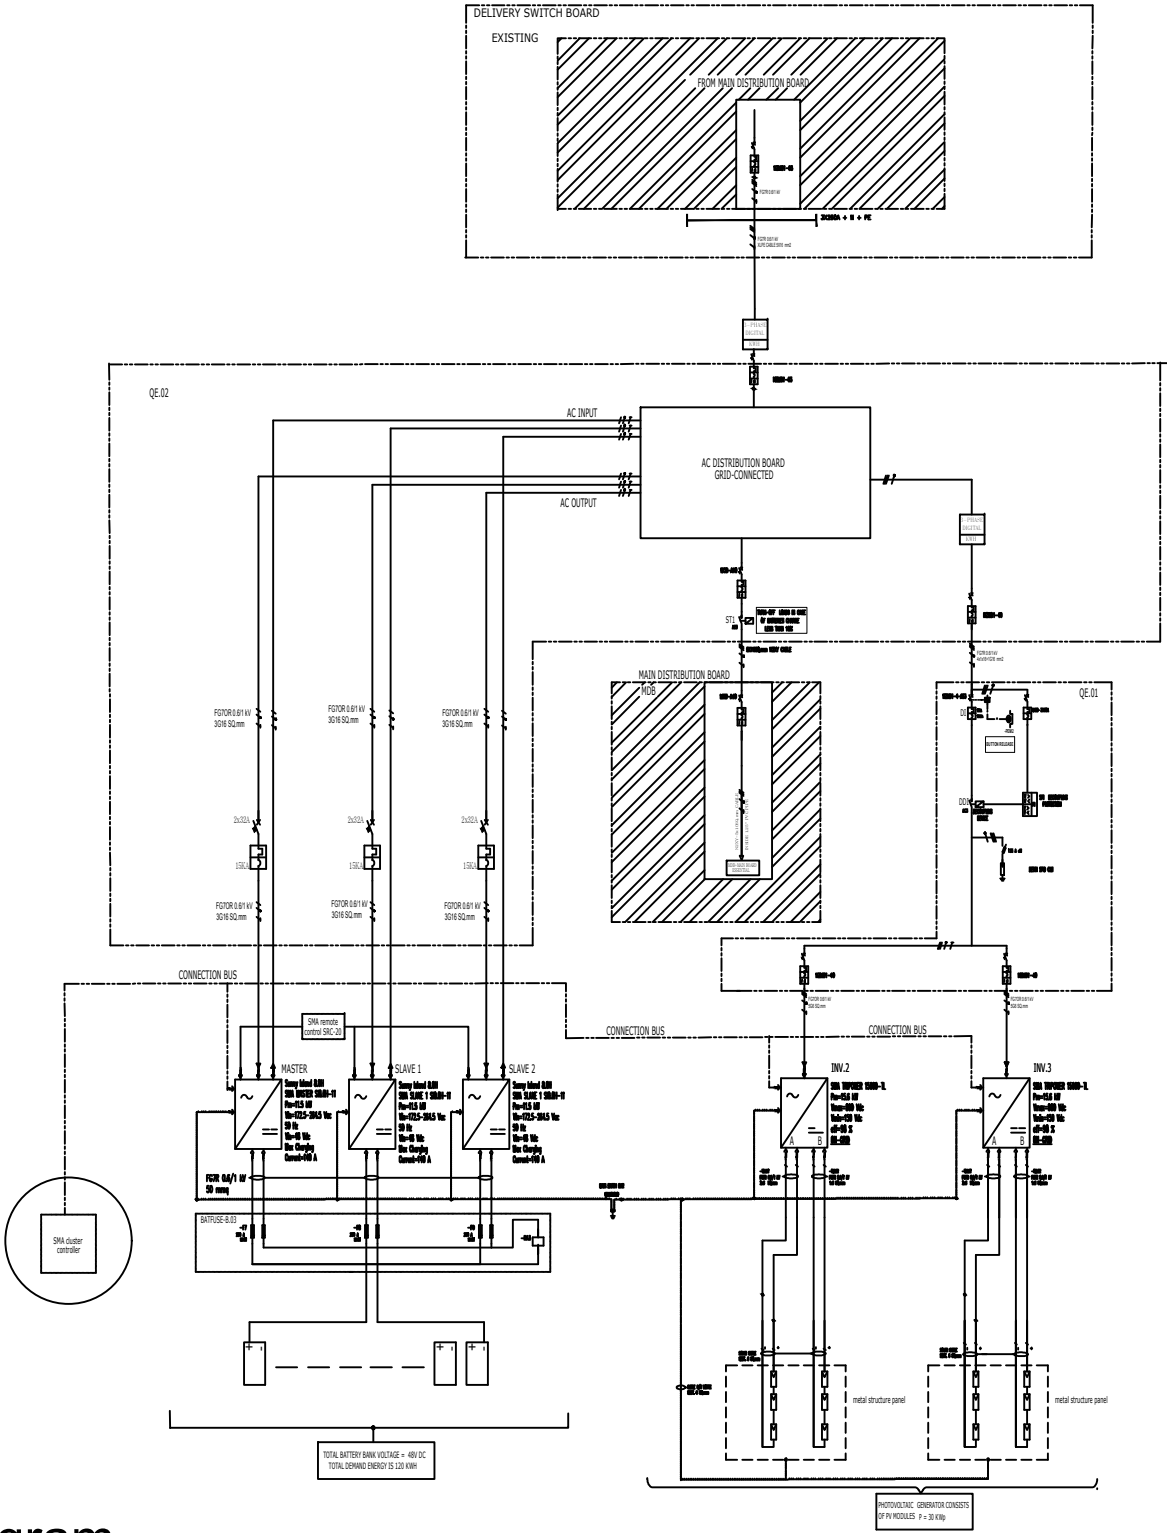

GRAPHIC SCALE			
0	1	2	3
4			
NO	DATE	ENG	REVISIONS

PROJECT TITLE
Reconstruction, Furniture and
Equipping of Three Schools
Photovoltaic Solar System for the
Greek Orthodox Patriarchate School
(PAL10-00099288)



CLIENT
Greek Orthodox Patriarchate School

FUNDED BY
 Kingdom of Saudi Arabia
Through The Saudi Fund
For Development (SFD)

Implemented By
 United Nations Relief and
Works Agency (UNRWA)
 United Nations Development
Programme (UNDP/PAPP)

CONSULTANT
 TECHNICAL ENGINEERING
CONSULTING COMPANY

DRAWING TITLE			
Solar System Single line Diagram			
PREPARED BY	SCALE	DRAWING NO.	
TECC	1:100	E01	
CHECKED BY	APPROVED BY	SERIAL NO.	
TECC	UNDP		
DRAWN BY	DATE		
TECC	August 2016		

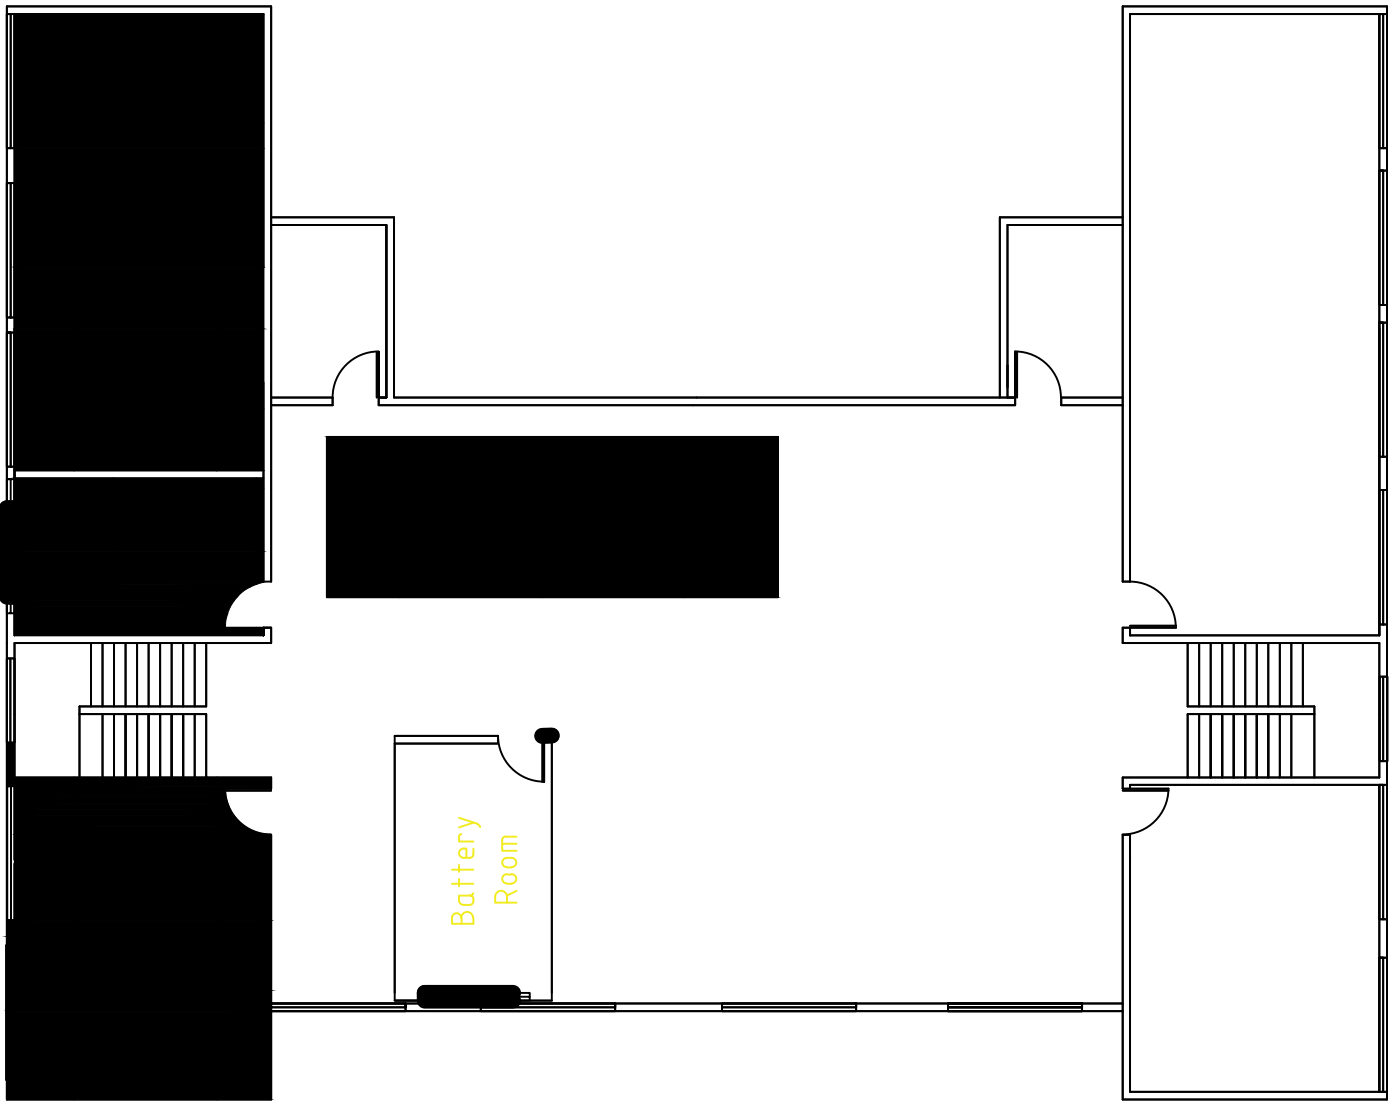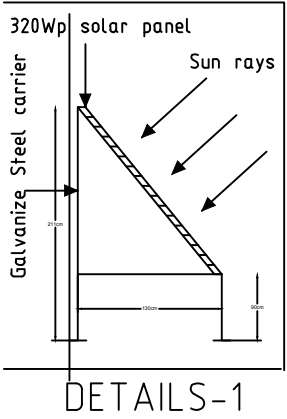

PV Cells -Roof Top Layout

GRAPHIC SCALE 0 1 2 3 4

NO DATE ENG REVISIONS

PROJECT TITLE

Reconstruction,Furniture and
Equipping of Three Schools
Photovoltaic Solar System for the
Greek Orthodox Patriarchate School
(PAL10-00099288)

CLIENT

Greek Orthodox Patriarchate School

FUNDED BY



Kingdom of Saudi Arabia
Through The Saudi Fund
For Development (SFD)

Implemented By



United Nations Relief And
Works Agency (UNRWA)



United Nations Development
Programme (UNDP/PAPP)

CONSULTANT




TECHNICAL ENGINEERING
CONSULTING COMPANY

DRAWING TITLE

DRAWING TITLE :
PV Cells -Roof Top Layout

PREPARED BY TECC	SCALE 1:100	DRAWING NO. E02
CHECKED BY TECC	APPROVED BY UNDP	SERIAL NO.
DRAWN BY TECC	DATE August 2016	

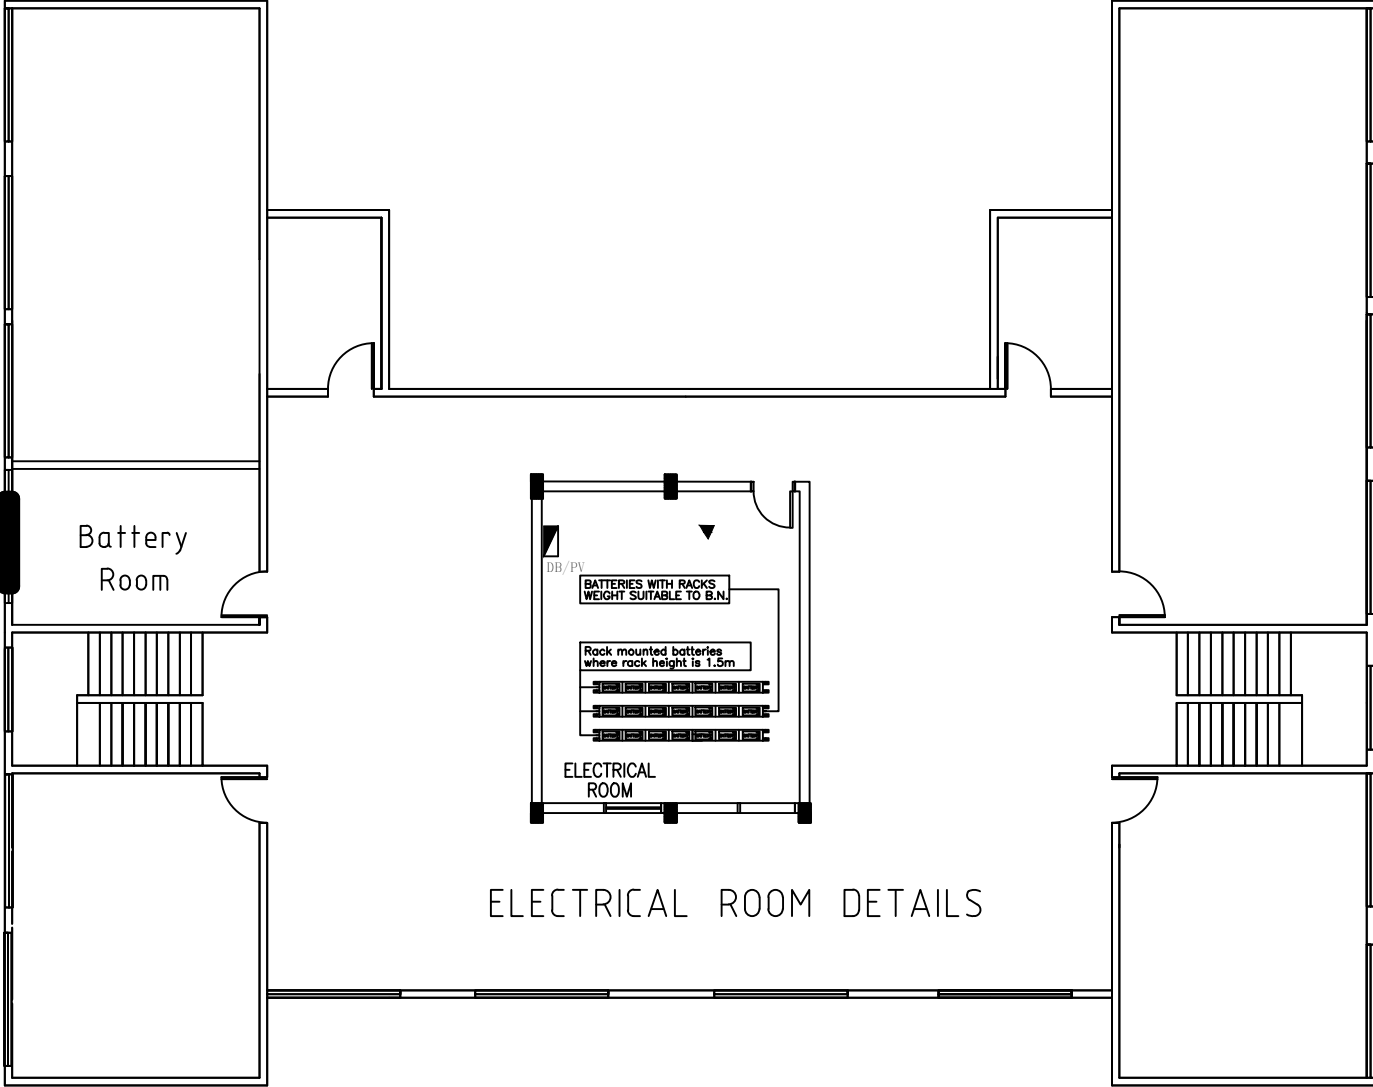

ELECTRICAL ROOM DETAILS

Battery Room Layout

GRAPHIC SCALE

01234

NO	DATE	ENG	REVISIONS

PROJECT TITLE

Reconstruction,Furniture and
Equipping of Three Schools

Photovoltaic Solar System for the
Greek Orthodox Patriarchate School
(PAL10-00099288)

CLIENT

Greek Orthodox Patriarchate School

FUNDED BY

Kingdom of Saudi Arabia
Through The Saudi Fund
For Development (SFD)

Implemented By

United Nations Relief And
Works Agency (UNRWA)

United Nations Development
Programme (UNDP/PAPP)


CONSULTANT

TECHNICAL ENGINEERING
CONSULTING COMPANY

DRAWING TITLE

DRAWING TITLE :
Battery Room Layout

PREPARED BY	SCALE	DRAWING NO.
TECC	1:100	E03
CHECKED BY	APPROVED BY	SERIAL NO.
TECC	UNDP	
DRAWN BY	DATE	
TECC	August 2016	

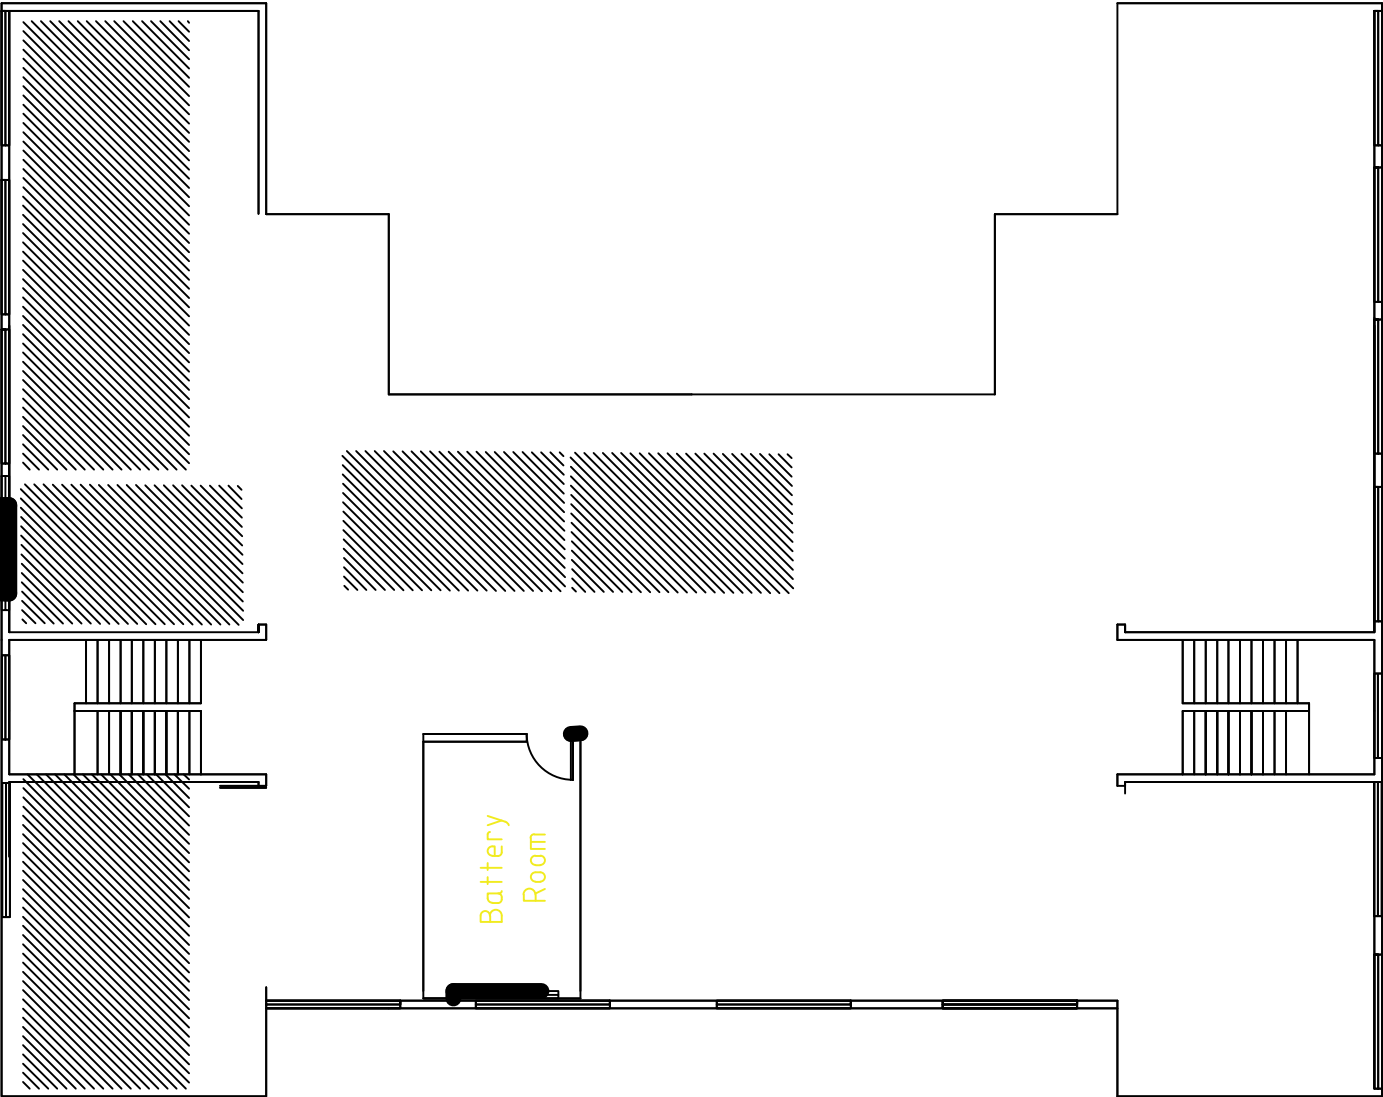

Weights of PV solar System Equipment

GRAPHIC SCALE 0 1 2 3 4

NO	DATE	ENG	REVISIONS

PROJECT TITLE
Reconstruction,Furniture and
Equipping of Three Schools
Photovoltaic Solar System for the
Greek Orthodox Patriarchate School
(PAL10-00099288)

CLIENT
Greek Orthodox Patriarchate School

FUNDED BY
 Kingdom of Saudi Arabia
Through The Saudi Fund
For Development (SFD)




Implemented By
 United Nations Relief And
Works Agency (UNRWA)
 United Nations Development
Programme (UNDP/PAPP)

CONSULTANT
 TECHNICAL ENGINEERING
CONSULTING COMPANY


DRAWING TITLE
Weights of PV solar System Equipment

PREPARED BY	SCALE	DRAWING NO.
TECC	1:100	E04
CHECKED BY	APPROVED BY	SERIAL NO.
TECC	UNDP	
DRAWN BY	DATE	
TECC	August 2016	

SHOP DRAWING

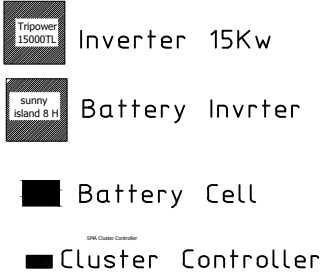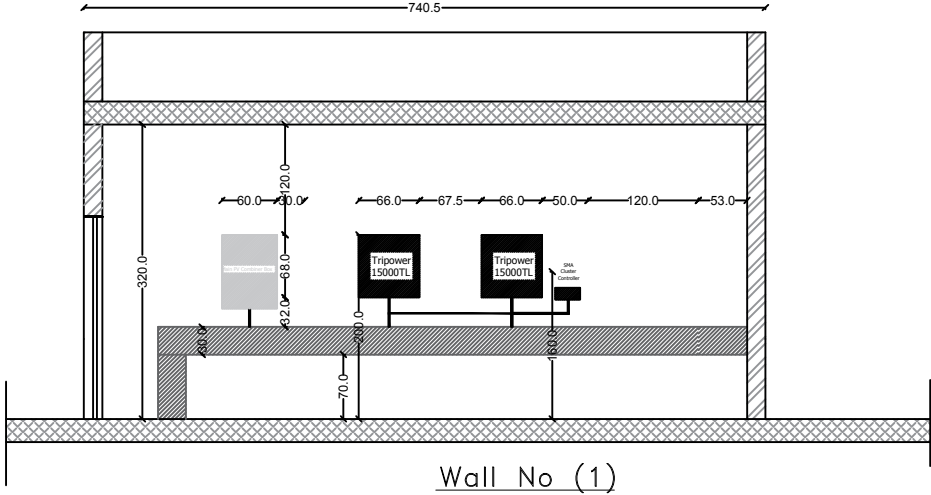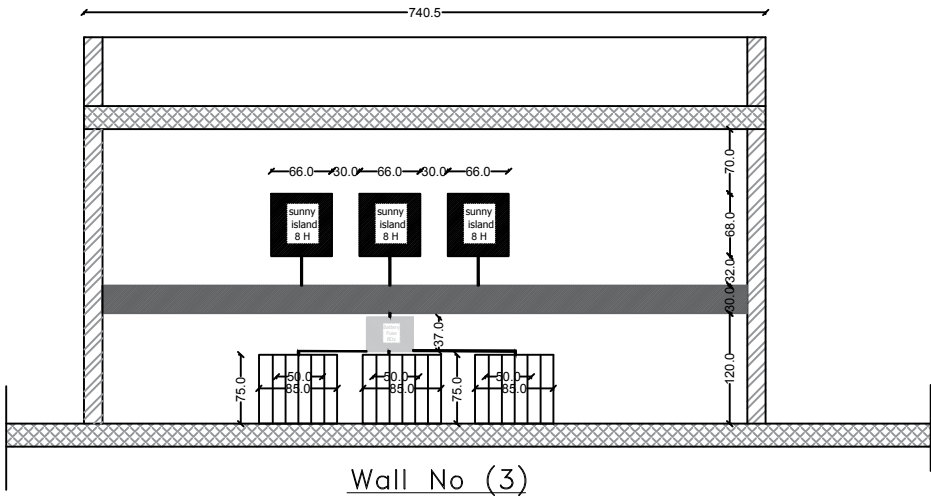

FUNDED BY:

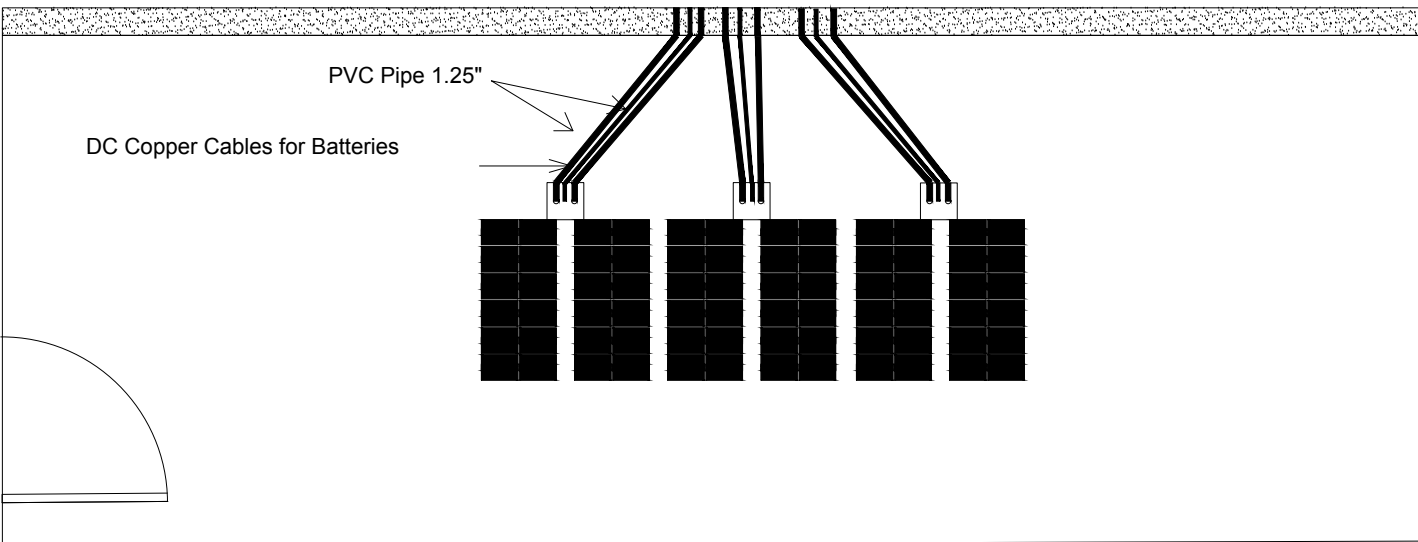

Top View

FOR THE BATTERY BANKS

GRAPHIC SCALE

NO	DATE	ENG	REVISIONS

PROJECT TITLE

**Reconstruction, Furniture and
Equipping of Three Schools**
**Photovoltaic Solar System for the
Greek Orthodox Patriarchate School**
(PAL10-00099288)

CLIENT

Greek Orthodox Patriarchate School

FUNDED BY



Kingdom of Saudi Arabia Through The Saudi Fund For Development (SFD)

Implemented By

**United Nations Relief And
Works Agency (UNRWA)**



United Nations Development Programme (UNDP/PAPP)

CONSULTANT



**TECHNICAL ENGINEERING
CONSULTING COMPANY**

DRAWING TITLE

PV Solar System Room layout


PREPARED BY TECC	SCALE 1:100	DRAWING NO. E04
CHECKED BY TECC	APPROVED BY UNDP	
DRAWN BY TECC	DATE August 2016	SERIAL NO.



GREEK ORTHODOX SCHOOL ELECTRICAL DRAWINGS

2017

GRAPHIC SCALE		
0 1 2 3 4		
NO	DATE	ENG
REVISIONS		
PROJECT TITLE		
Reconstruction,Furniture and Equipping of Three Schools		
Photovoltaic Solar System for the Greek Orthodox Patriarchate School (PAL10-00099288)		
CLIENT		
Greek Orthodox Patriarchate School		
FUNDED BY		
	Kingdom of Saudi Arabia Through The Saudi Fund For Development (SFD)	
Implemented By		
	United Nations Relief And Works Agency (UNRWA)	
	United Nations Development Programme (UNDP/PAPP)	
CONSULTANT		
	TECHNICAL ENGINEERING CONSULTING COMPANY	
DRAWING TITLE		
DRAWING TITLE :		
PREPARED BY	SCALE	DRAWING NO.
TECC	1:100	E00
CHECKED BY	APPROVED BY	SERIAL NO.
TECC	UNDP	
DRAWN BY	DATE	
TECC	August 2016	

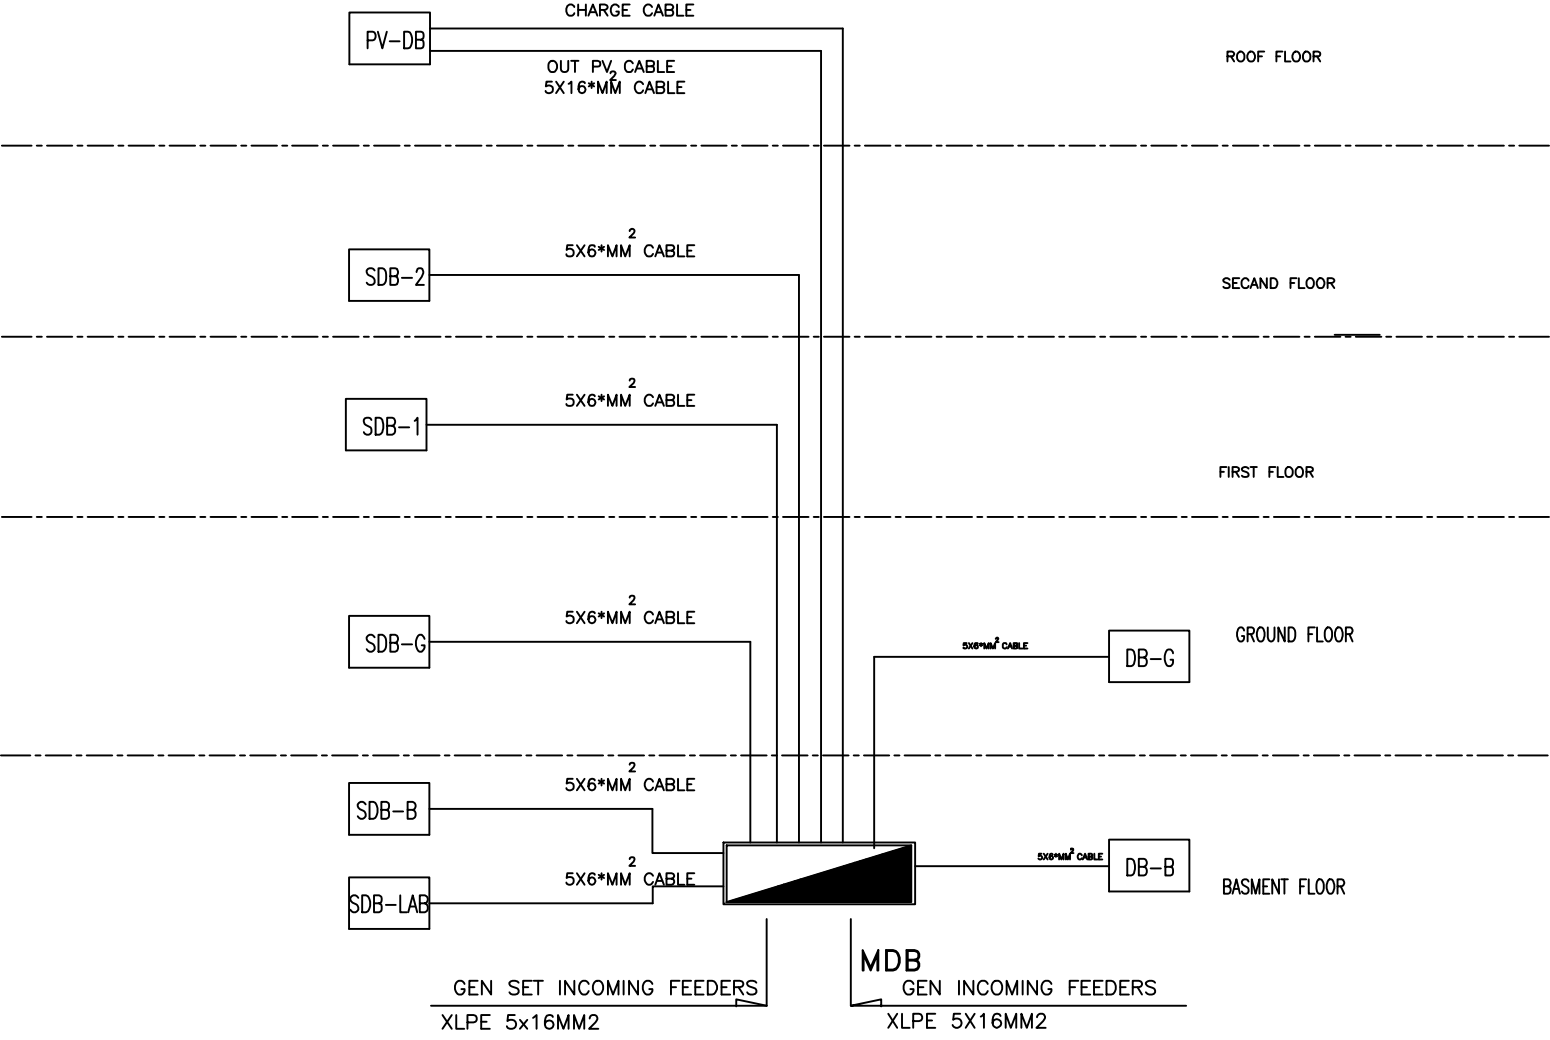

GRAPHIC SCALE			
0	1	2	3 4
NO	DATE	ENG	REVISIONS

PROJECT TITLE
Reconstruction,Furniture and
Equipping of Three Schools
Photovoltaic Solar System for the
Greek Orthodox Patriarchate School
(PAL10-00099288)


CLIENT
Greek Orthodox Patriarchate School

FUNDED BY
 Kingdom of Saudi Arabia
 Through The Saudi Fund
For Development (SFD)

Implemented By
 United Nations Relief And
Works Agency (UNRWA)
 United Nations Development
Programme (UNDP/PAPP)

CONSULTANT
 TECHNICAL ENGINEERING
CONSULTING COMPANY

DRAWING TITLE		
DRAWING TITLE : Distribution Boards Riser Layout		
PREPARED BY TECC	SCALE 1:100	DRAWING NO. E05
CHECKED BY TECC	APPROVED BY UNDP	
DRAWN BY TECC	DATE August 2016	SERIAL NO.

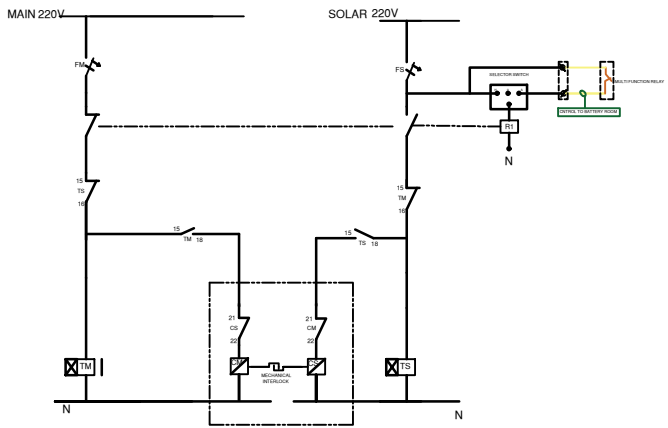

GRAPHIC SCALE		
		0 1 2 3 4
NO	DATE	ENG REVISIONS

PROJECT TITLE
**Reconstruction,Furniture and
Equipping of Three Schools**
**Photovoltaic Solar System for the
Greek Orthodox Patriarchate School**
(PAL10-00099288)

CLIENT
Greek Orthodox Patriarchate School

FUNDED BY

 Kingdom of Saudi Arabia
 Through The Saudi Fund
For Development (SFD)

Implemented By

**United Nations Relief And
Works Agency (UNRWA)**




**United Nations Development
Programme (UNDP/PAPP)**

CONSULTANT

 **TECHNICAL ENGINEERING
CONSULTING COMPANY**

DRAWING TITLE
DRAWING TITLE :
PV - Main Distribution Board Layout

PREPARED BY TECC	SCALE 1:100	DRAWING NO. E06
CHECKED BY TECC	APPROVED BY UNDP	SERIAL NO.
DRAWN BY TECC	DATE August 2016	

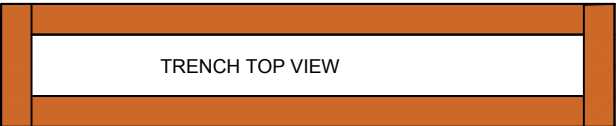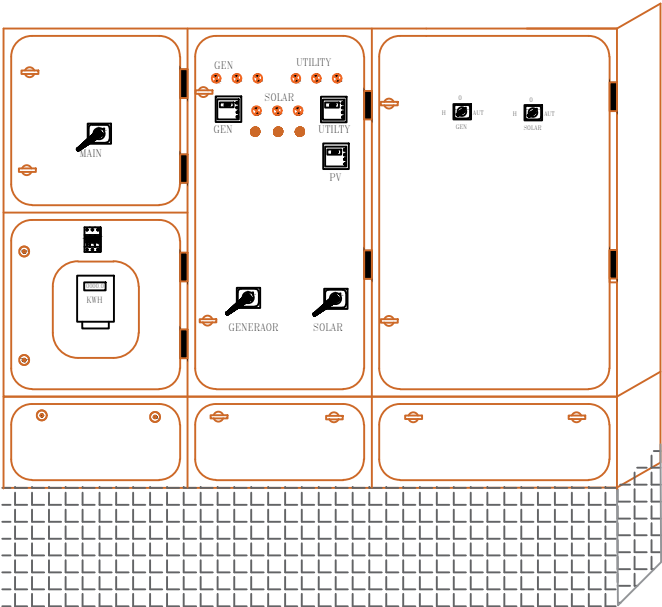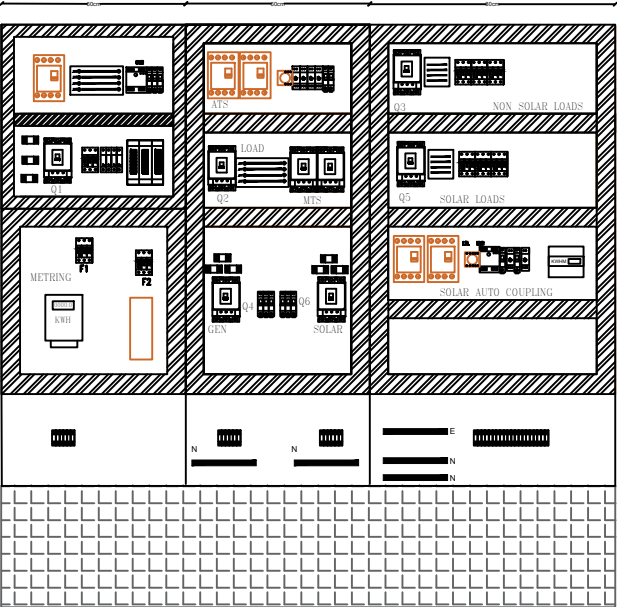

GRAPHIC SCALE			
0	1	2	3
4			
NO	DATE	ENG	REVISIONS

PROJECT TITLE
Reconstruction,Furniture and
Equipping of Three Schools
Photovoltaic Solar System for the
Greek Orthodox Patriarchate School
(PAL10-00099288)

CLIENT
Greek Orthodox Patriarchate School






FUNDED BY
 Kingdom of Saudi Arabia
Through The Saudi Fund
For Development (SFD)

Implemented By
 United Nations Relief And
Works Agency (UNRWA)
 United Nations Development
Programme (UNDP/PAPP)

CONSULTANT
 TECHNICAL ENGINEERING
CONSULTING COMPANY

DRAWING TITLE
DRAWING TITLE :
Main Distribution Board Layout

PREPARED BY TECC	SCALE 1:100	DRAWING NO. E07
CHECKED BY TECC	APPROVED BY UNDP	SERIAL NO.
DRAWN BY TECC	DATE August 2016	

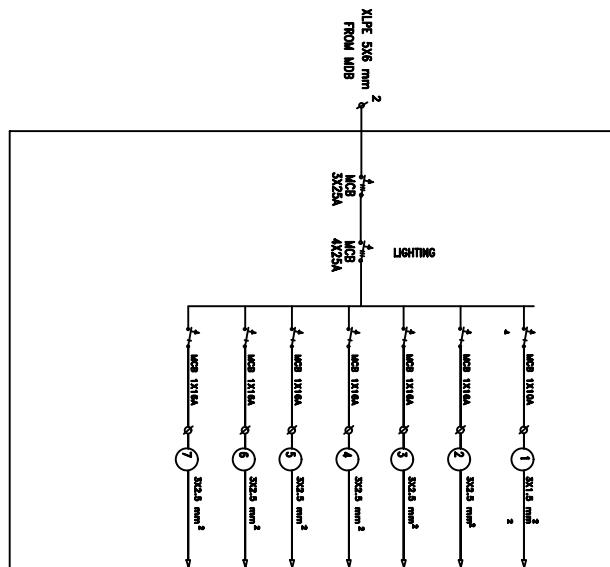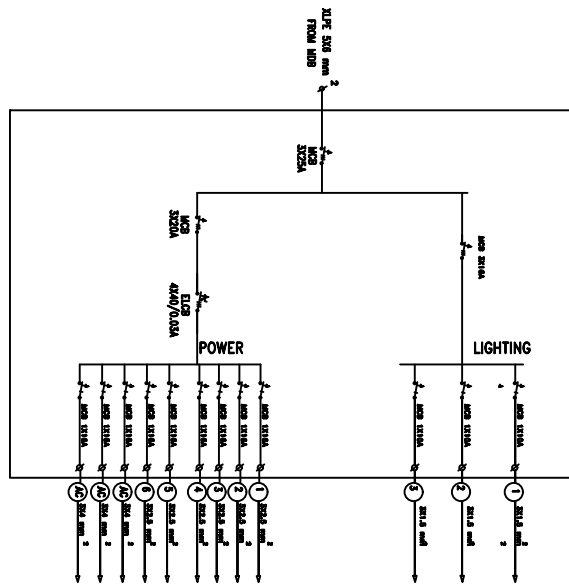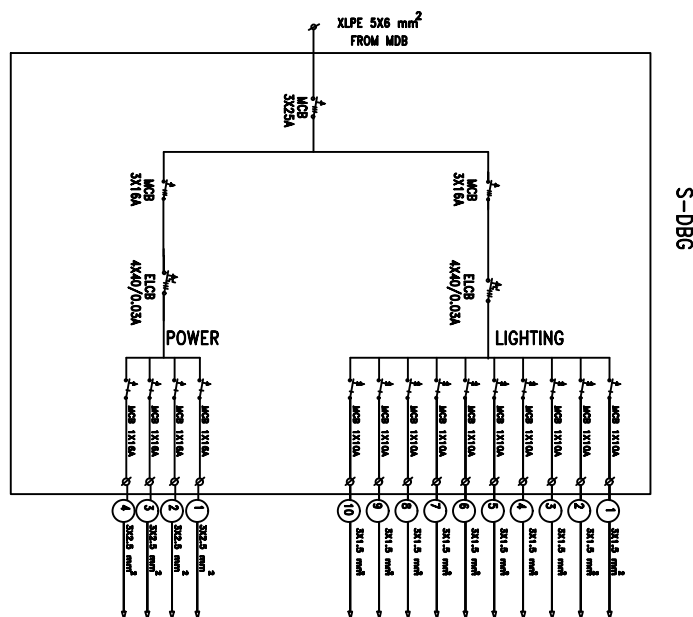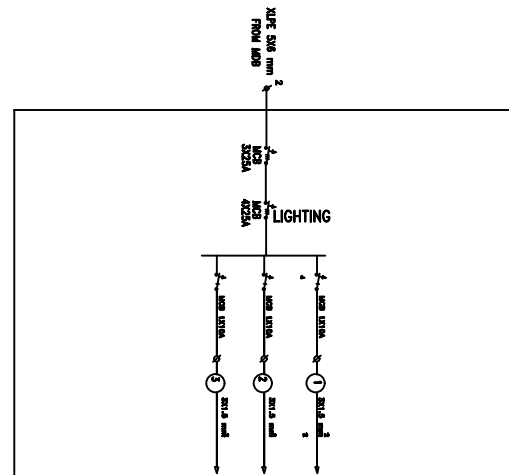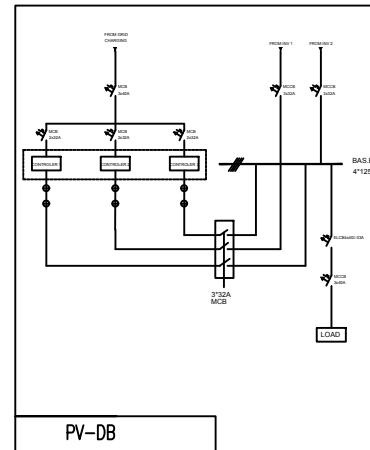

GRAPHIC SCALE			
NO	DATE	ENG	REVISIONS

PROJECT TITLE

**Reconstruction, Furniture and
Equipping of Three Schools**

**Photovoltaic Solar System for the
Greek Orthodox Patriarchate School**

(PAL10-00099288)

**Photovoltaic Solar System for the
Greek Orthodox Patriarchate School
(PAL10-00099288)**

CLIENT

Greek Orthodox Patriarchate School

FUNDED BY	
------------------	--



**Kingdom of Saudi Arabia
Through The Saudi Fund
For Development (SFD)**

<u>Implemented By</u>



**United Nations Relief And
Works Agency (UNRWA)**



United Nations Development Programme (UNDP/PAPP)

CONSULTANT




**TECHNICAL ENGINEERING
CONSULTING COMPANY**

DRAWING TITLE

DRAWING TITLE :
Distribution Board Layout

PREPARED BY TECC	SCALE 1:100	DRAWING NO. E08
CHECKED BY TECC	APPROVED BY UNDP	
DRAWN BY TECC	DATE August 2016	SERIAL NO.

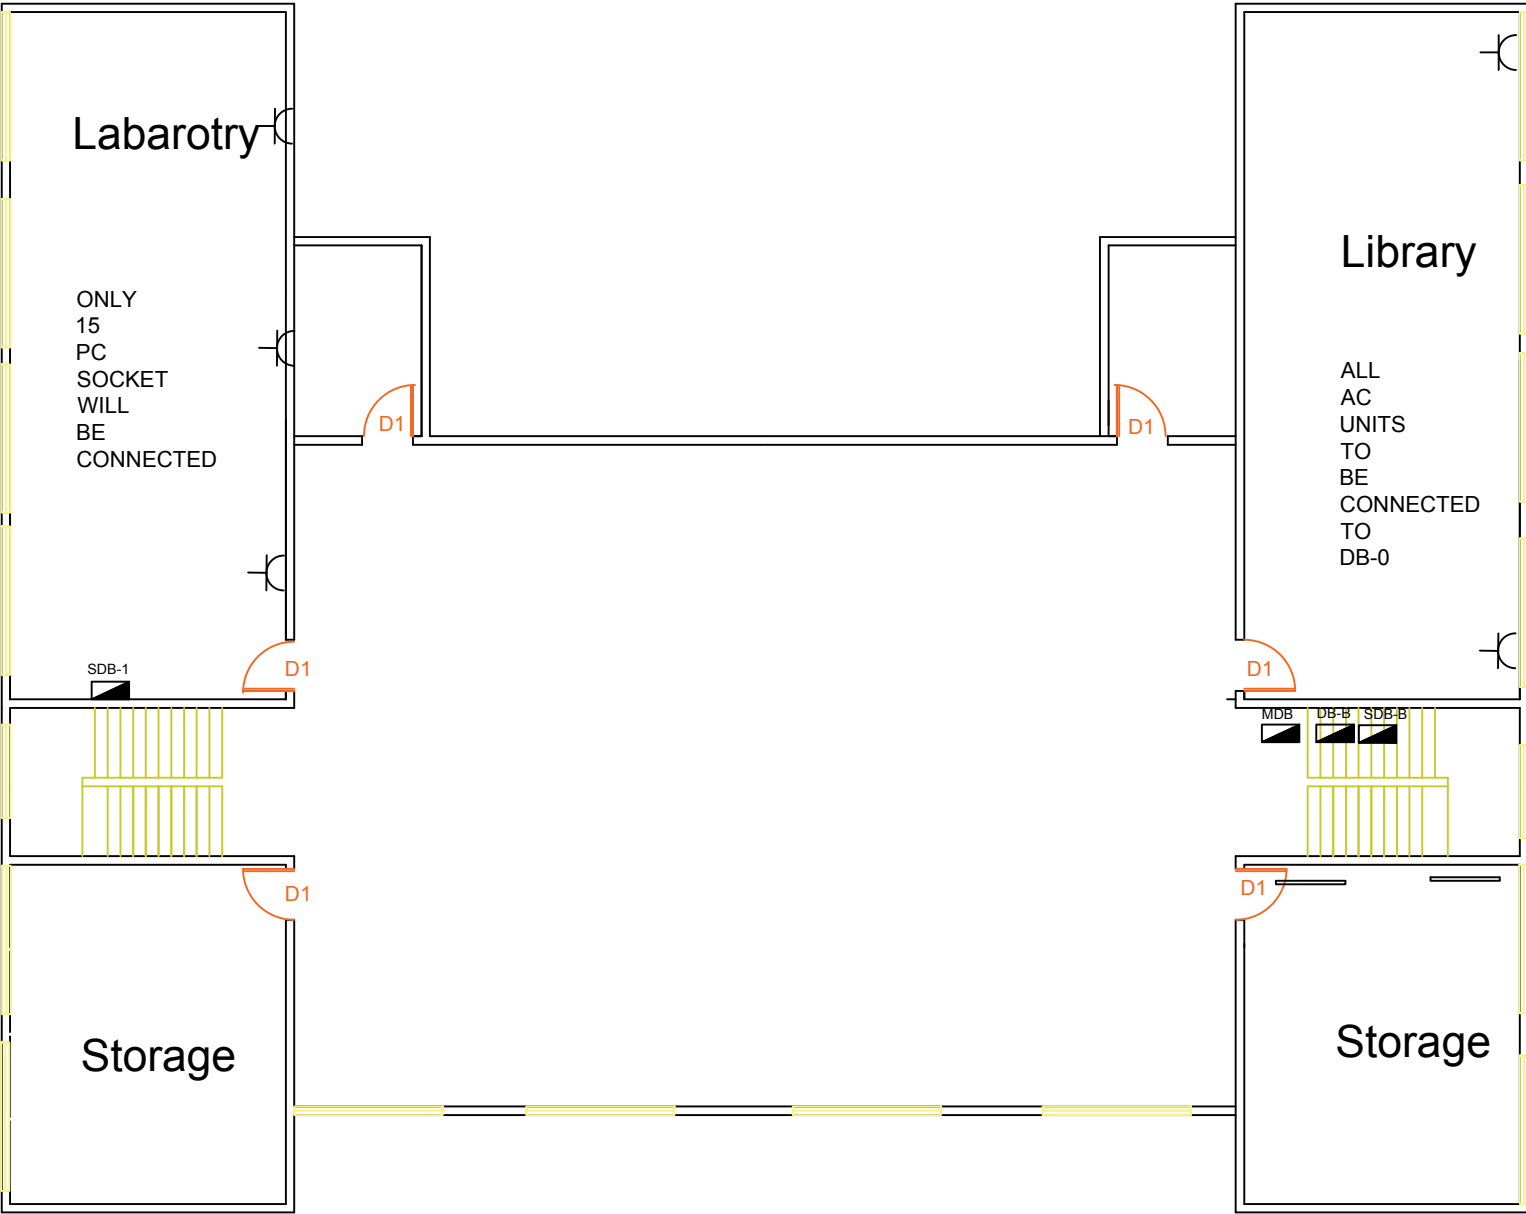

Basment Floor

GRAPHIC SCALE			
0	1	2	3
4			
NO	DATE	ENG	REVISIONS

PROJECT TITLE
Reconstruction,Furniture and
Equipping of Three Schools
Photovoltaic Solar System for the
Greek Orthodox Patriarchate School
(PAL10-00099288)


CLIENT
Greek Orthodox Patriarchate School

FUNDED BY
 Kingdom of Saudi Arabia
Through The Saudi Fund
For Development (SFD)

Implemented By
 United Nations Relief And
Works Agency (UNRWA)
 United Nations Development
Programme (UNDP/PAPP)

CONSULTANT
 TECHNICAL ENGINEERING
CONSULTING COMPANY

DRAWING TITLE			
Basment floor distribution boards layout			
PREPARED BY	SCALE	DRAWING NO.	
TECC	1:100	E09	
CHECKED BY	APPROVED BY	SERIAL NO.	
TECC	UNDP		
DRAWN BY	DATE		
TECC	August 2016		

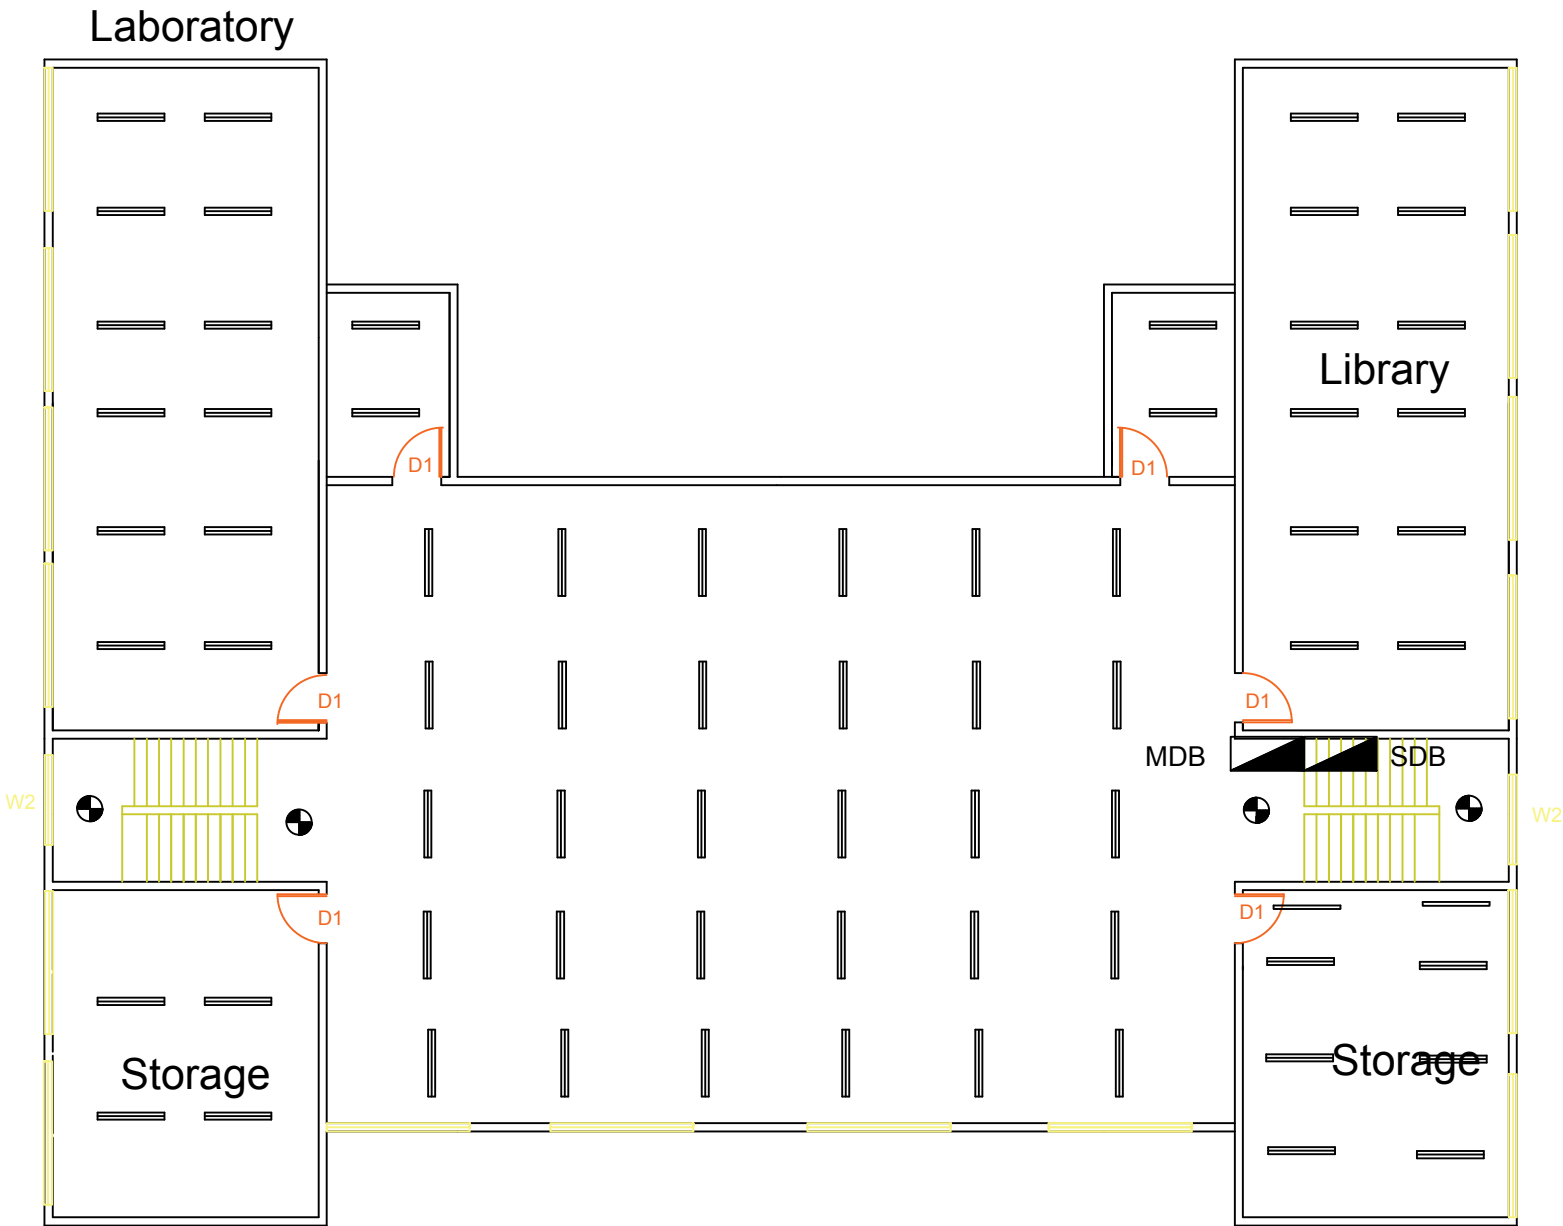

GRAPHIC SCALE 0 1 2 3 4

NO DATE ENG REVISIONS

PROJECT TITLE

Reconstruction, Furniture and
Equipping of Three Schools
Photovoltaic Solar System for the
Greek Orthodox Patriarchate School
(PAL10-00099288)

CLIENT

Greek Orthodox Patriarchate School

FUNDED BY



Kingdom of Saudi Arabia
Through The Saudi Fund
For Development (SFD)

Implemented By



United Nations Relief And
Works Agency (UNRWA)



United Nations Development
Programme (UNDP/PAPP)

CONSULTANT



TECHNICAL ENGINEERING
CONSULTING COMPANY


DRAWING TITLE

BASMENT FLOOR LIGHT FITTINGS

PREPARED BY TECC	SCALE 1:100	DRAWING NO. E11
CHECKED BY TECC	APPROVED BY UNDP	SERIAL NO.
DRAWN BY TECC	DATE	



GRAPHIC SCALE 0 1 2 3 4			
NO	DATE	ENG	REVISIONS
PROJECT TITLE			
Reconstruction,Furniture and Equipping of Three Schools			
Photovoltaic Solar System for the Greek Orthodox Patriarchate School (PAL10-00099288)			
CLIENT			
Greek Orthodox Patriarchate School			
FUNDED BY			
 Kingdom of Saudi Arabia Through The Saudi Fund For Development (SFD)			
Implemented By			
 United Nations Relief And Works Agency (UNRWA)			
 United Nations Development Programme (UNDP/PAPP)			
CONSULTANT			
 TECHNICAL ENGINEERING CONSULTING COMPANY			
DRAWING TITLE			
GROUND FLOOR LIGHT FITTINGS			
PREPARED BY	SCALE	DRAWING NO.	
TECC	1:100	E12	
CHECKED BY	APPROVED BY	SERIAL NO.	
TECC	UNDP		
DRAWN BY	DATE		
TECC			

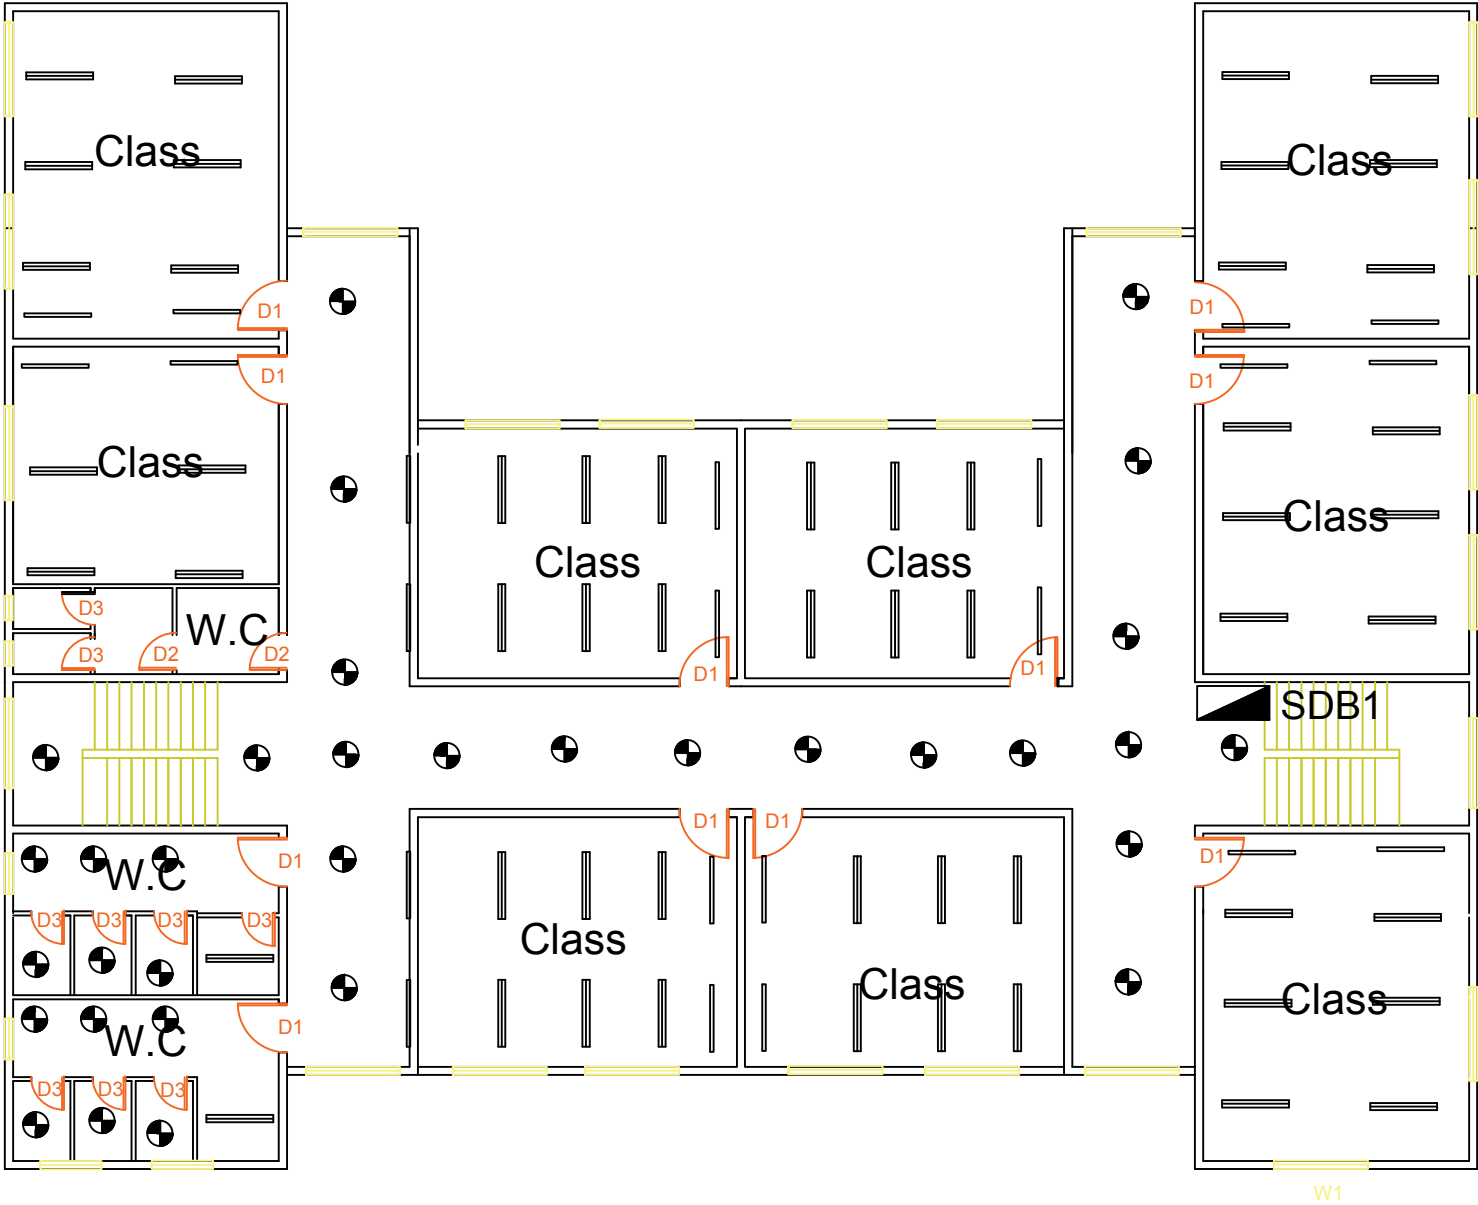

GRAPHIC SCALE 0 1 2 3 4

NO DATE ENG REVISIONS

PROJECT TITLE
Reconstruction, Furniture and
Equipping of Three Schools
Photovoltaic Solar System for the
Greek Orthodox Patriarchate School
(PAL10-00099288)

CLIENT
Greek Orthodox Patriarchate School


FUNDED BY
 Kingdom of Saudi Arabia
Through The Saudi Fund
For Development (SFD)

Implemented By
 United Nations Relief And
Works Agency (UNRWA)
 United Nations Development
Programme (UNDP/PAPP)

CONSULTANT
 TECHNICAL ENGINEERING
CONSULTING COMPANY

DRAWING TITLE
FIRST FLOOR LIGHT FITTINGS

PREPARED BY TECC	SCALE 1:100	DRAWING NO. E13
CHECKED BY TECC	APPROVED BY UNDP	SERIAL NO.
DRAWN BY TECC	DATE	

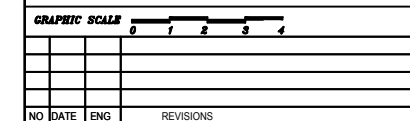

**Reconstruction, Furniture and
Equipping of Three Schools**

**Photovoltaic Solar System for the
Greek Orthodox Patriarchate School**
(PAL10-00099288)

FUNDED BY

 **Kingdom of Saudi Arabia
Through The Saudi Fund
For Development (SFD)**

Implemented By

 **United Nations Relief And Works Agency (UNRWA)**

 **United Nations Development Programme (UNDP/PAPP)**

CONSULTANT
 **TECHNICAL ENGINEERING
CONSULTING COMPANY**

DRAWING TITLE

SECOND FLOOR LIGHT FITTINGS

PREPARED BY TECC	SCALE 1:100	DRAWING NO. E14
CHECKED BY TECC	APPROVED BY UNDP	
DRAWN BY TECC	DATE	SERIAL NO.