

No.	Description	Drawing No.
01	GENERAL LAYOUT	L-01
02	AERIAL VIEW	A
03	AERIAL VIEW	B
04	FLOOR PLAN	F1
05	FRONT ELEVATION	O2
06	BACK ELEVATION	O3
07	LEFT & RIGHT ELEVATION	O4
08	SECTION A-A	O5
09	ROOF PLAN	O6
10	CEILING PLAN	O7
11	FLOOR PLAN (First Draft Proposed)	O8
12	FLOOR PLAN (Final Draft)	O9
13	FLOOR PLAN (Door Plan)	O10
14	FLOOR PLAN (Window Plan)	O11
15	ELECTRICAL PLAN	O12
16	DOOR AND WINDOW DETAIL	O13
17	FOOTING PLAN	O14
18	GROUND BEAM PLAN	O15
19	ROOF BEAM PLAN	O16
20	RIDGE BEAM PLAN	O17
21	R.C. FOOTING DETAIL	O18
22	R.C. COLUMN DETAIL	O19
23	R.C. GROUND BEAM DETAIL	O20


[illegible][illegible]

MINISTRY OF AGRICULTURE AND FORESTRY (MAF)

DEPARTMENT OF FOREST RESOURCES MANAGEMENT (DFRM)	REV No	DESCRIPTION	DATE	NAME	SIGNATURE	DATE	DRAWING TITLE	DRAWING NO
							DORMITORY AT VISIT CENTER	SCALE
							CENTRAL	

ໂຄງການ ອະນຸລັກລະບົບນິເວດປ່າໂຄກ

Sustainable Forest and Land Management
in the Dry Dipterocarp Forest Ecosystems

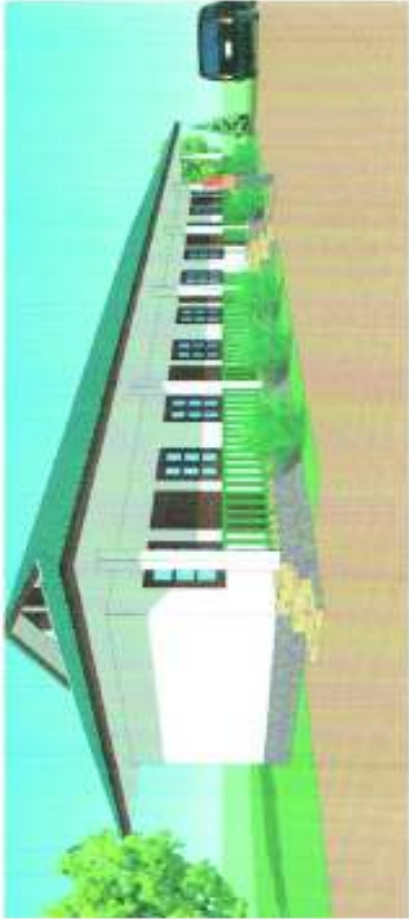


ຫໍພັກ

Dormitory at Visit Center

MINISTRY OF AGRICULTURE AND FORESTRY (MAF) DEPARTMENT FOR FOREST RESOURCES MANAGEMENT (DFRM)	Sustainable Forest and Land Management in the Dry Dipterocarp Forest Ecosystems of Southern Lao PDR									
	REV. NO.	DESCRIPTION	DATE	DESIGNED BY	NAME	SIGNATURE	DATE	DRAWING TITLE	DRAWING NO.	
				CHECKED BY				DORMITORY AT VISIT CENTER	A	
				APPROVED BY					SCALE	




MINISTRY OF AGRICULTURE AND FORESTRY (MAF) FOR FOREST RESOURCES MANAGEMENT (DFRM)	Sustainable Forest and Land Management in the Dry Dipterocarp Forest Ecosystems of Southern Lao PDR									
	REV. NO.	DESCRIPTION	DATE	DESIGNED BY	MAF	SIGNATURE	DATE	DRAWING TITLE	DRAWING NO.	
				CHECKED BY:				DOHITORY AT VISIT CENTER	SCALE	
				APPROVED BY:				ANNUAL REPORT		

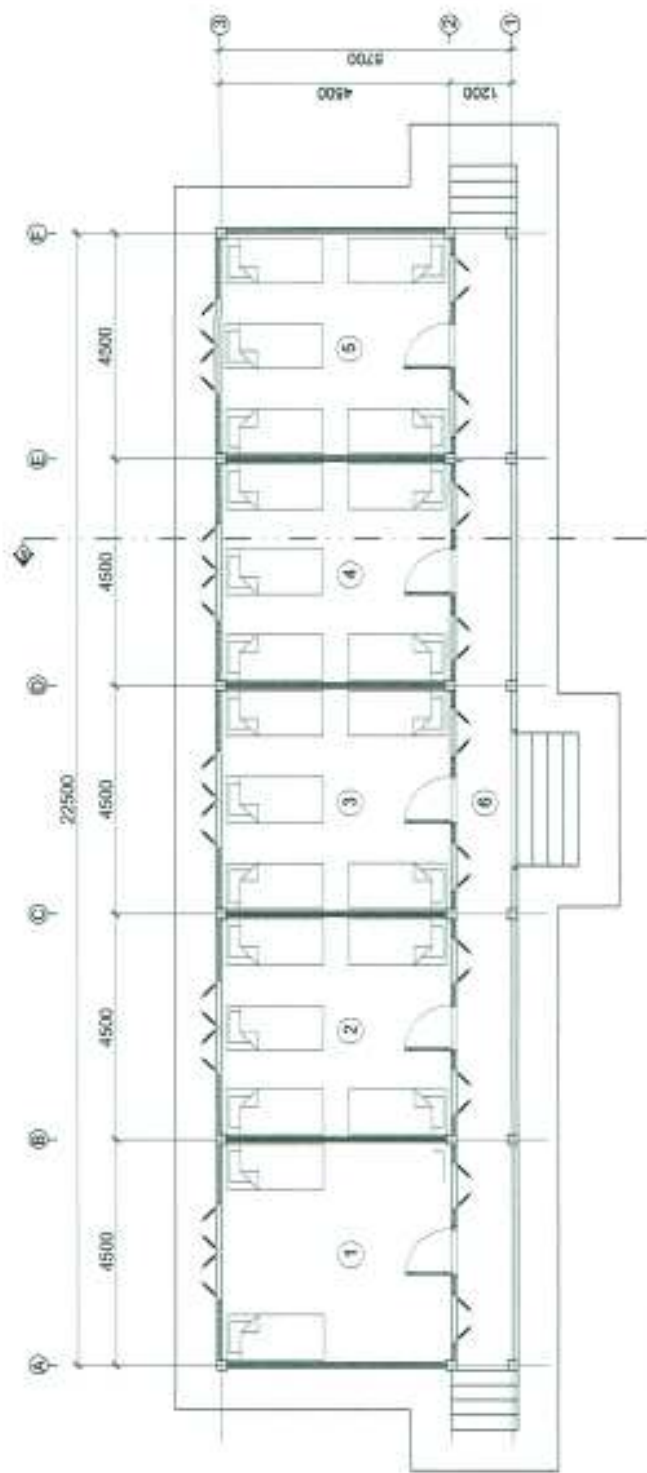


AREA:

Sustainable Forest and Land Management in the Dry Dipterocarp Forest Ecosystems of Southern Lao PDR

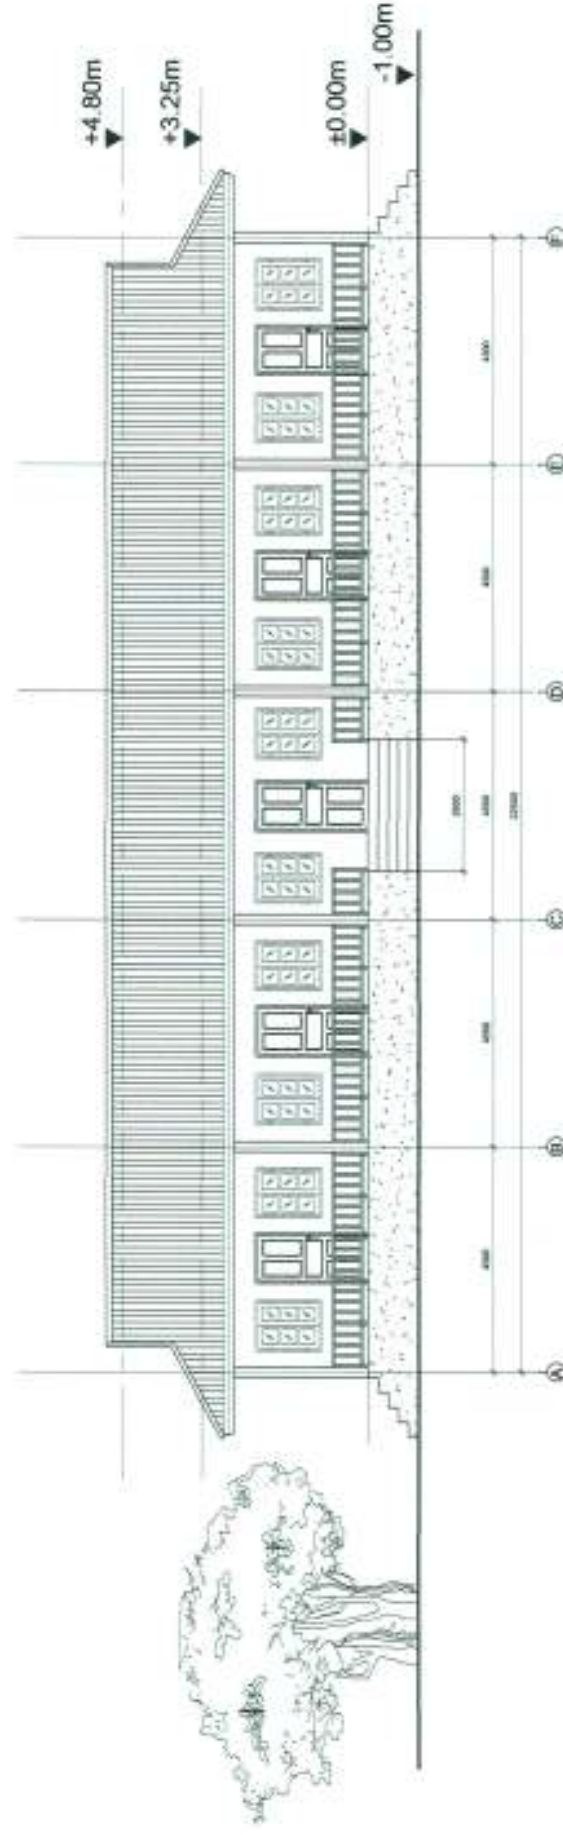


FRONT ELEVATION 1/100

MINISTRY OF AGRICULTURE AND FORESTRY (MAF) DEPARTMENT FOR FOREST RESOURCES MANAGEMENT (DFRM)	Sustainable Forest and Land Management in the Dry Dipterocarp Forest Ecosystems of Southern Lao PDR							
	REV. NO.	DESCRIPTION	DATE	REVISIONARY CHECKED BY APPROVED BY	NAME	SIGNATURE	DATE	DRAWING NO. 02
								DRAWING TITLE DORMITORY AT VISIT CENTER FOOT ELEVATION SCALE

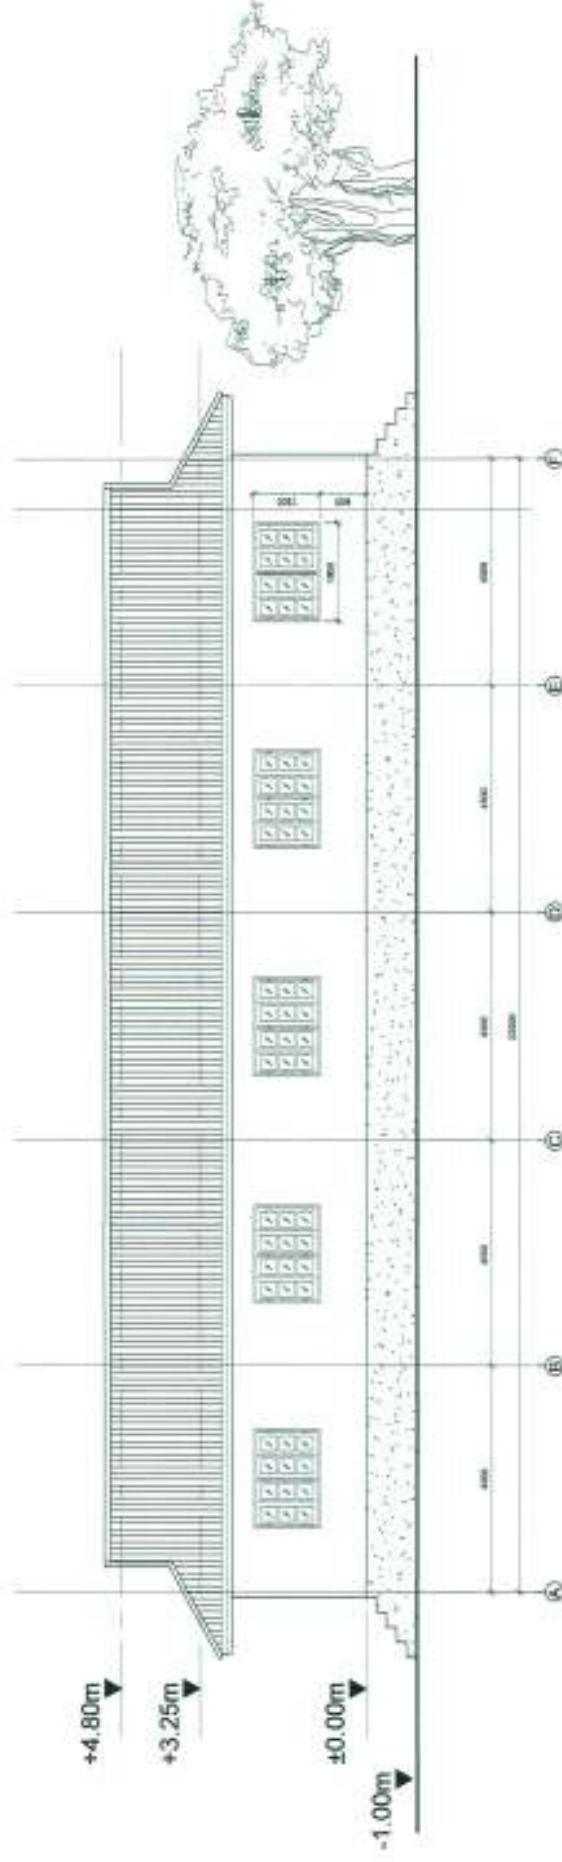


BACK ELEVATION 1/100

MINISTRY OF AGRICULTURE AND FORESTRY (MAF) DEPARTMENT FOR FOREST RESOURCES MANAGEMENT (DFRM)	Sustainable Forest and Land Management in the Dry Dipterocarp Forest Ecosystems of Southern Lao PDR					
	REV. NO.	DESCRIPTION	DATE	DESIGNED BY	NAME	DRAWING TITLE
				DRAWN BY	SIGNATURE	DATE
				APPROVED BY		DOCTORARY AT VISIT CENTER
						BACK ELEVATION
						SCALE

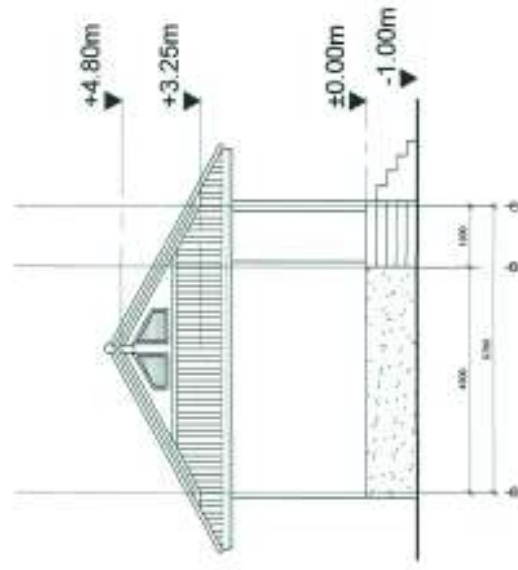


LEFT ELEVATION 1/100

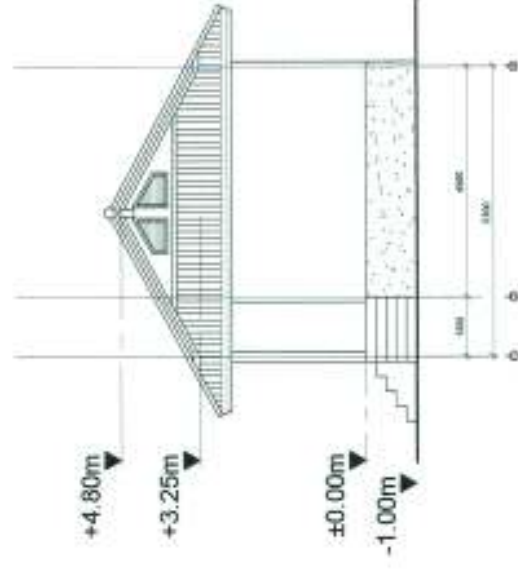

RIGHT ELEVATION 1/100

MINISTRY OF AGRICULTURE AND FORESTRY (MAF) DEPARTMENT FOR FOREST RESOURCES MANAGEMENT (DFRM)	Sustainable Forest and Land Management in the Dry Dipterocarp Forest Ecosystems of Southern Lao PDR									
	REV. NO.	DESCRIPTION	DATE	DESIGNED BY	NAME	REVIEWER	DATE	DRAWING TITLE	DRAWING NO.	SCALE
				CHECKED BY				DORMITORY AT VISIT CENTER LEFT & RIGHT ELEVATION	04	

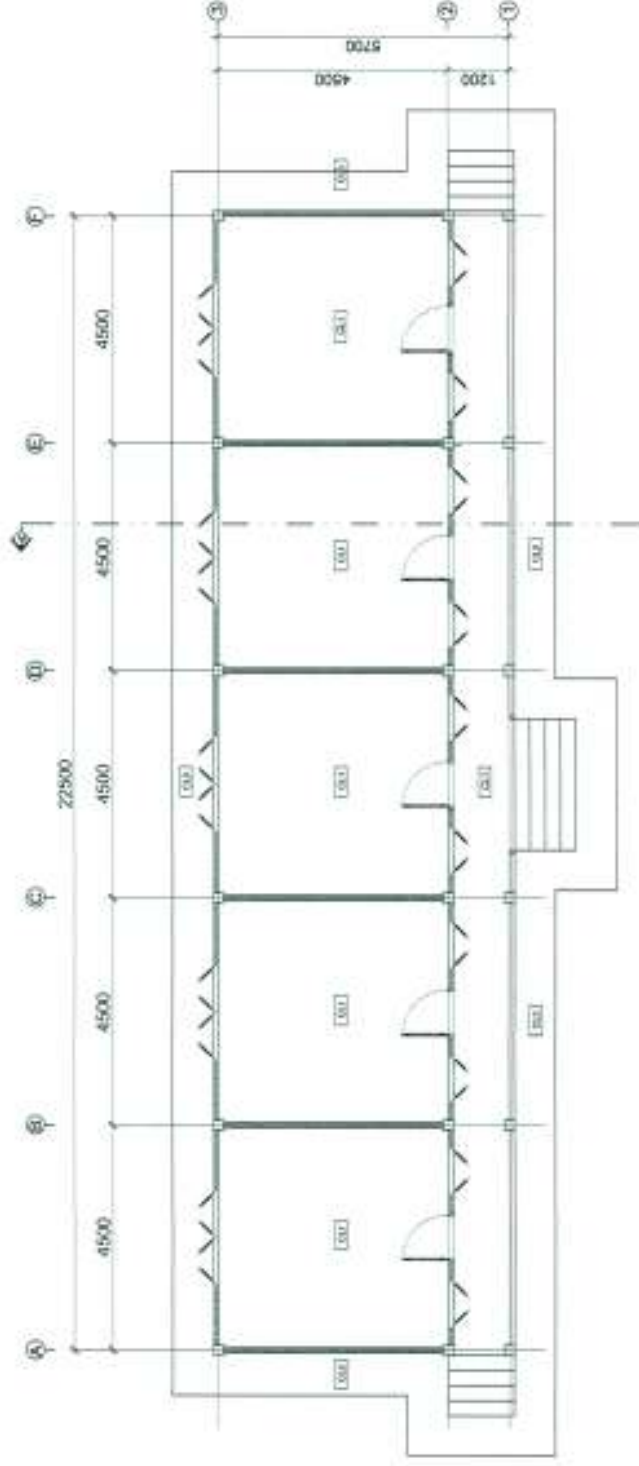

ສັນຍາລັກ

CL1	ແຜນພື້ນທີ່, ທາງ CL Line
CL2	ໂຄງສ້າງພື້ນທີ່ ສະ ພາ
CL3	ແຜນ ໂຄງສ້າງພື້ນທີ່ ທາງ CL Line


CEILING PLAN 1:100

MINISTRY OF AGRICULTURE AND FORESTRY (MAF)

DEPARTMENT
FOR
FOREST RESOURCES MANAGEMENT (DFRM)

Sustainable Forest and Land Management in the Dry Dipterocarp Forest Ecosystems of Southern Lao PDR

REV. NO.	DESCRIPTION	DATE	DESIGNED BY	DRAWN BY	DATE	DRAWING TITLE	COMPOUND NO.
						DORMITORY AT VISIT CENTER	07
						CEILING PLAN	SCALE

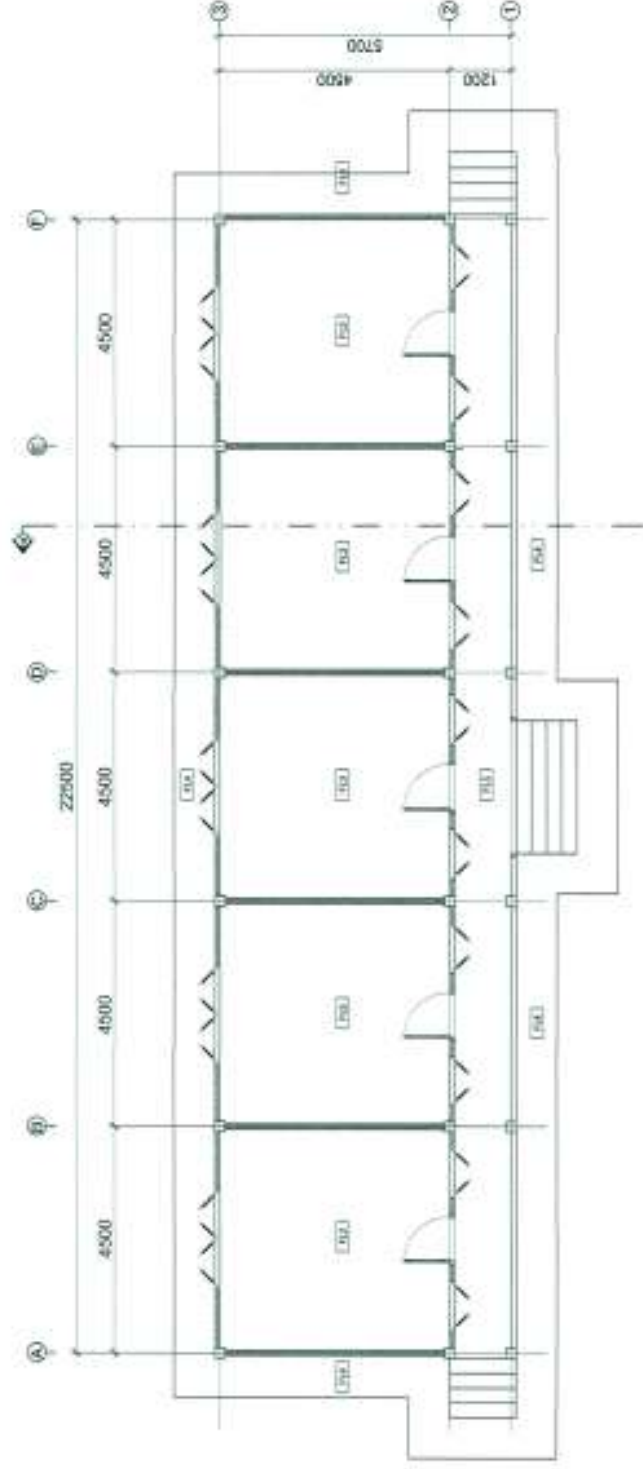

ສັນຍາລັກ

	ໜ້າ 300x300mm
PL1	ໜ້າລະຫັດ 300x300mm
PL3	ໜ້າລະຫັດ 600x600mm
PL4	Footpath

FLOOR PLAN (Floor Detail Finishes) 1:100


MINISTRY OF AGRICULTURE AND FORESTRY (MAF)

DEPARTMENT
FOR

FOREST RESOURCES MANAGEMENT (DFRM)

Sustainable Forest and Land Management in the Dry Dipterocarp Forest Ecosystems of Southern Lao PDR

REV. NO.	DESCRIPTION	DATE	DESIGNED BY	CHECKED BY	APPROVED BY	NAME	SIGNATURE	DATE	DRAWING TITLE	DRAWING NO. (S)	SCALE
									DORMITORY AT VISIT CENTER FLOOR PLAN (Floor Detail Finishes)		

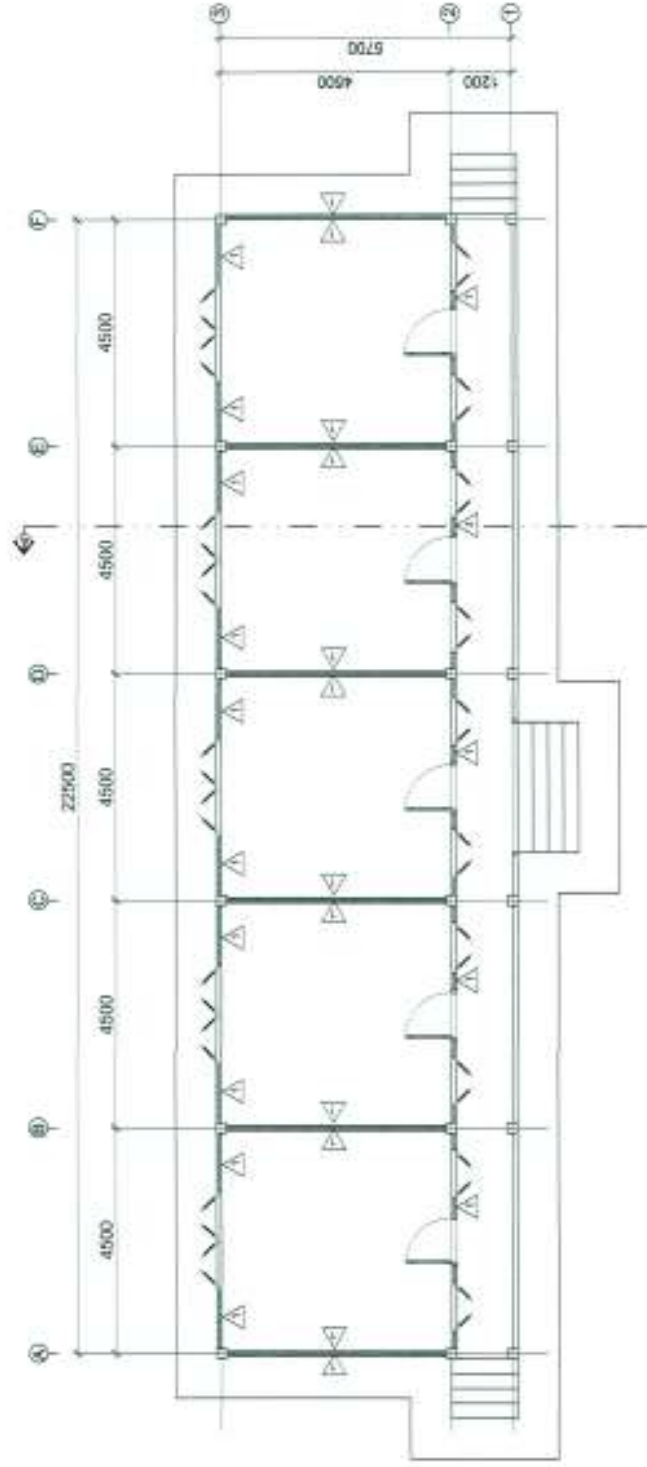

ສັນຍາສັນຍາ

△	ຈຸດຕັ້ງສະຖານ
△	ຈຸດຕັ້ງສະຖານ 120mm
△	ຈຸດຕັ້ງສະຖານ 200x400mm
△	ຈຸດຕັ້ງສະຖານ 100x100

FLOOR PLAN (Wall Detail) 1:100


MINISTRY OF AGRICULTURE AND FORESTRY (MAF)

DEPARTMENT
FOR

FOREST RESOURCES MANAGEMENT (DFRM)

Sustainable Forest and Land Management in the Dry Dipterocarp Forest Ecosystems of Southern Lao PDR

REV. NO.	DESCRIPTION	DATE	DESIGNED BY	CHECKED BY	APPROVED BY	NAME	SIGNATURE	DATE	DRAWING TITLE	DRAWING NO. (P)
									DORMITORY AT VISIT CENTER	SCALE
									FLOOR PLAN (wall detail)	

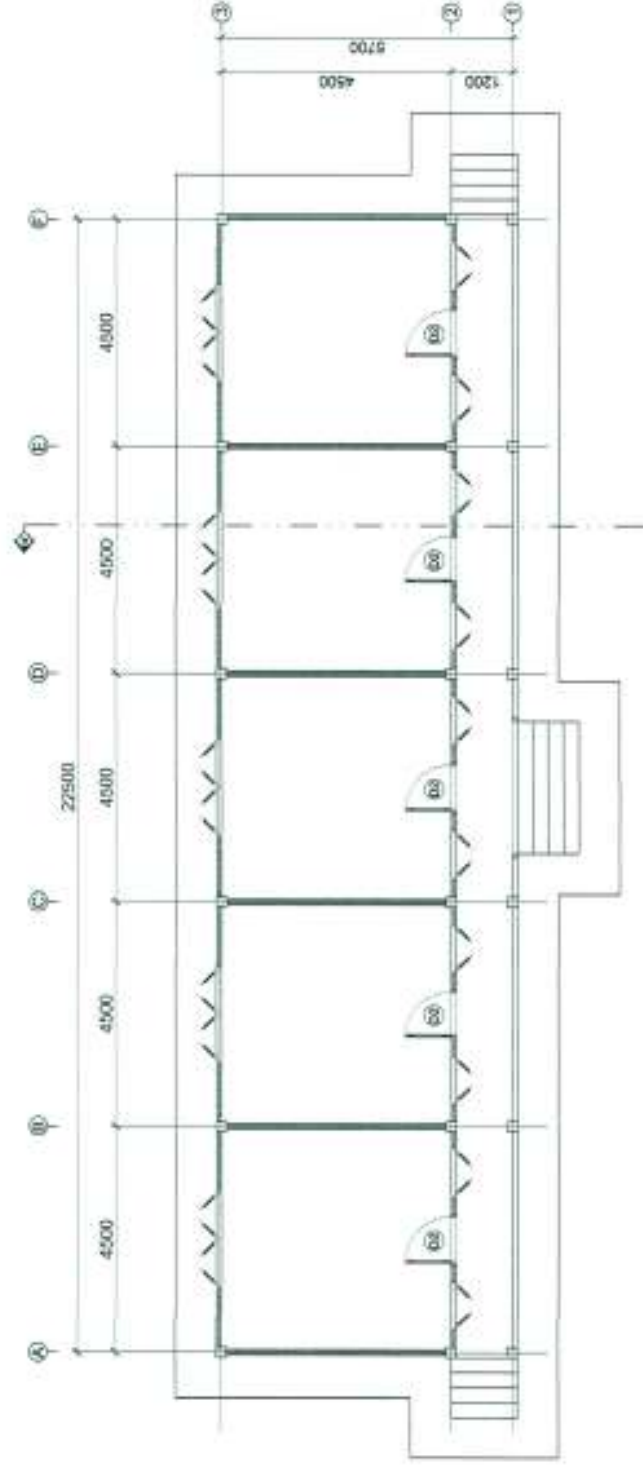


FLOOR PLAN (Door Plan) 1:100

MINISTRY OF AGRICULTURE AND FORESTRY (MAF)
DEPARTMENT
FOR
FOREST RESOURCES MANAGEMENT (DFRM)

Sustainable Forest and Land Management in the Dry Dipterocarp Forest Ecosystems of Southern Lao PDR

DEPARTMENT										DRAWING NO 10
FOR										
FOREST RESOURCES MANAGEMENT (DPRM)										SCALE
REV. No.	DESCRIPTION	DATE	DESIGNED BY	CHECKED BY	APPROVED BY	NAME	SIGNATURE	DATE	DRAWING TITLE	
									DORMITORY AT VISIT CENTER FLOOR PLAN (Door Plan)	

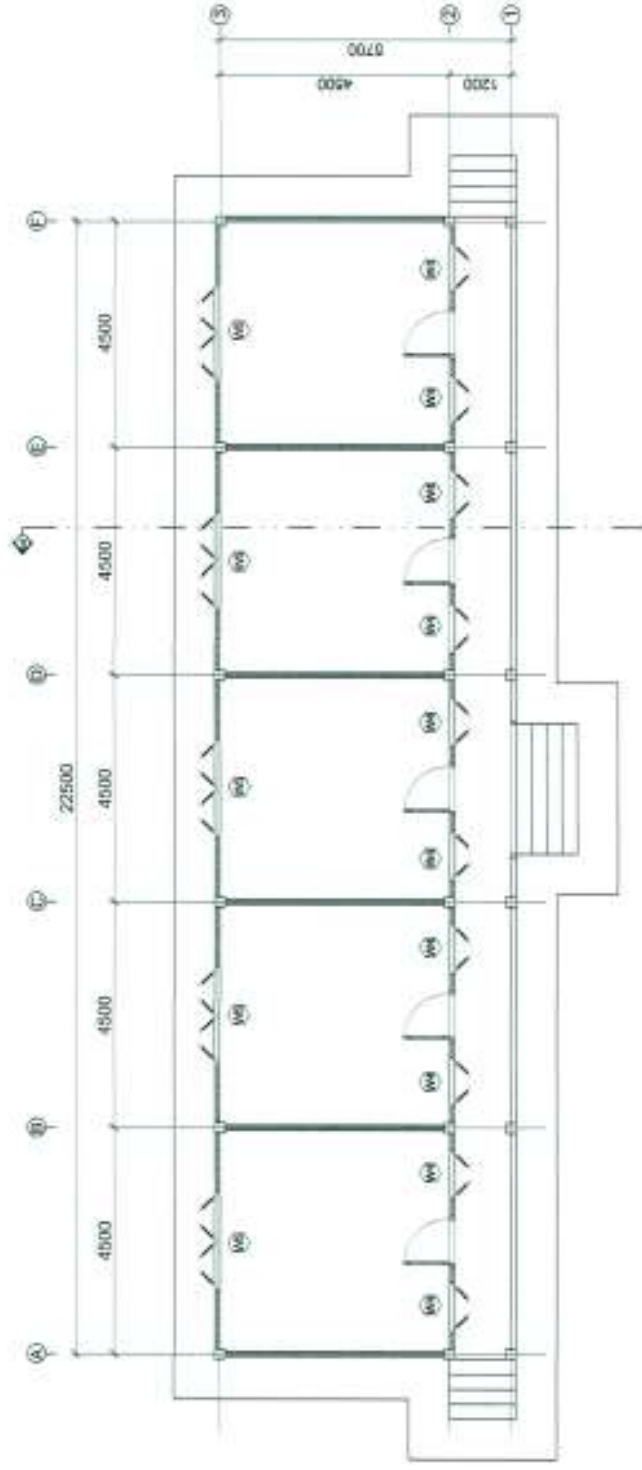

FLOOR PLAN (Window Plan) 1:100

ສັນຕິພາບ


001	ໂຮງຮຽນ/ສູນຮຽນ, 2,000x1,000mm ສະໜອງ
002	ໂຮງຮຽນ/ສູນຮຽນ, 2,000x1,000mm ສະໜອງ
003	ໂຮງຮຽນ/ສູນຮຽນ, 2,000x1,000mm ສະໜອງ
004	ໂຮງຮຽນ/ສູນຮຽນ, 2,000x1,000mm ສະໜອງ

MINISTRY OF AGRICULTURE AND FORESTRY (MAF)


DEPARTMENT
FOR
FOREST RESOURCES MANAGEMENT (DFRM)

Sustainable Forest and Land Management in the Dry Dipterocarp Forest Ecosystems of Southern Lao PDR

DATE	DESIGNED BY	NAME	SIGNATURE	DATE	DRAWING TITLE	DATE
	CHECKED BY				DORMITORY AT VISIT CENTER	11
	APPROVED BY				Floor plan (Window Plan)	SCALE

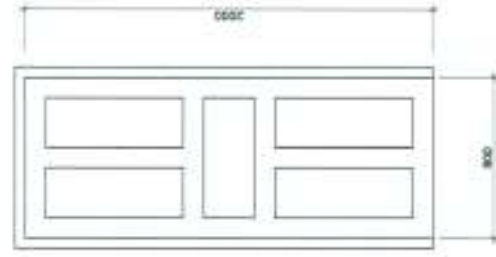


DOOR (D2)

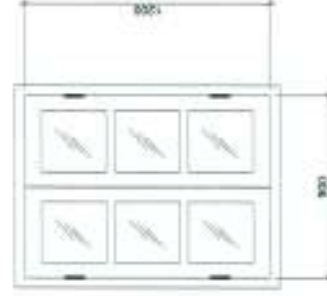

WINDOW (W4)




WINDOW (W5)

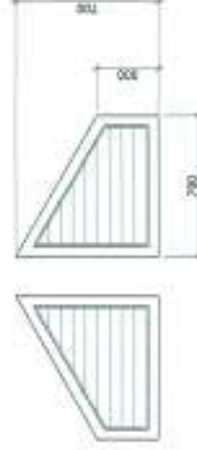

LOUVER FIXED WINDOW (W6)

MINISTRY OF AGRICULTURE AND FORESTRY (MAF) DEPARTMENT FOR FOREST RESOURCES MANAGEMENT (DFRM)	Sustainable Forest and Land Management in the Dry Dipterocarp Forest Ecosystems of Southern Lao PDR					DRAWING NO.	15
	DESCRIPTION		DATE	SIGNATURE	NAME	DRAWING TITLE	
	REV. NO.		DATE	DESIGNED BY	CHECKED BY	APPROVED BY	DORMITORY AT VISIT CENTER DOOR AND WINDOW DETAIL

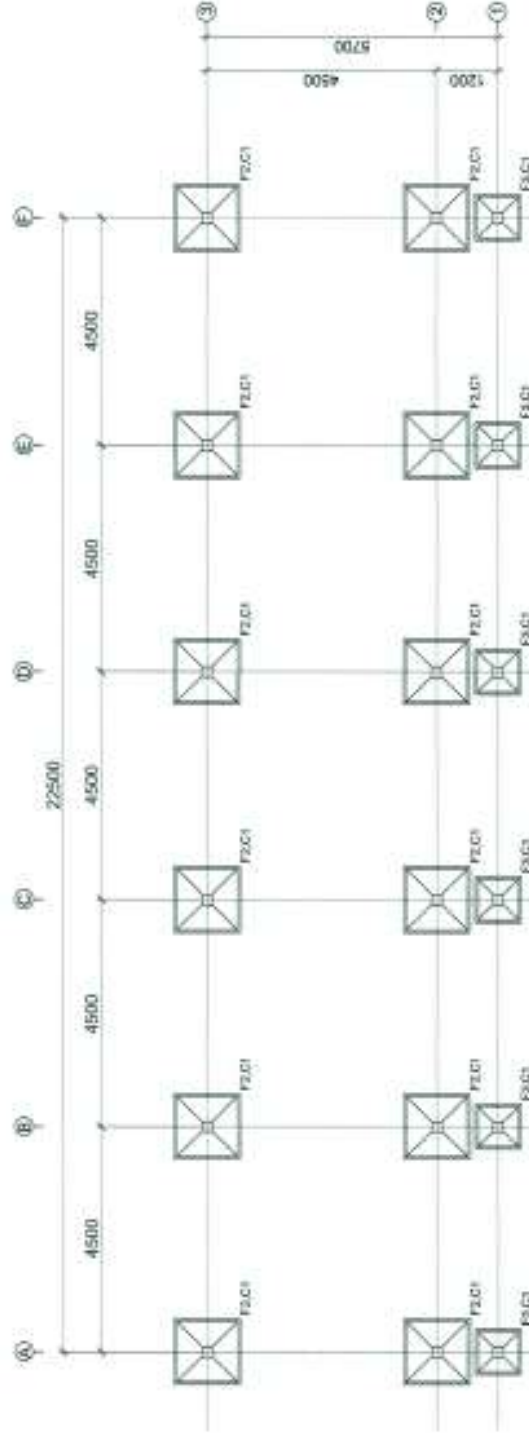


FOOTING PLAN 1:100

MINISTRY OF AGRICULTURE AND FORESTRY (MAF)

DEPARTMENT
FOR
FOREST RESOURCES MANAGEMENT (DFRM)

Sustainable Forest and Land Management in the Dry Dipterocarp Forest Ecosystems of Southern Lao PDR


REF. NO.	DESCRIPTION	DATE	REVISION	NAME	SIGNATURE	DATE	DRAWING TITLE	DRAWING NO.
							DORMITORY AT WEST CENTER	1.4
							FOOTING PLAN	SCALE

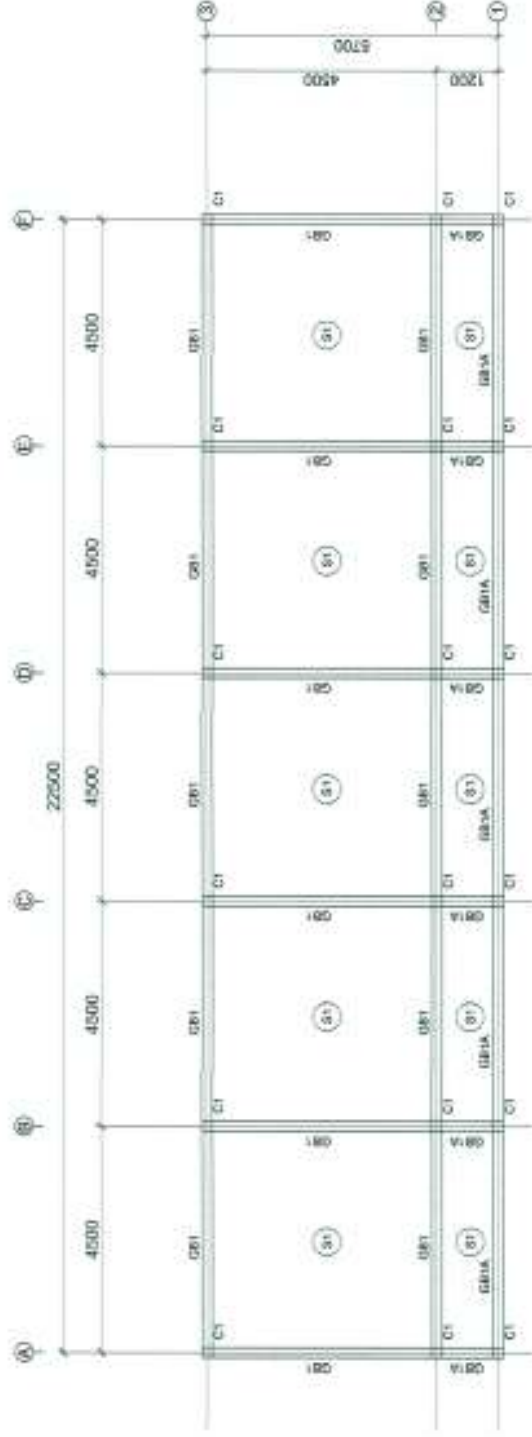

GROUND BEAM PLAN 1:100

Sustainable Forest and Land Management in the Dry Dipterocarp Forest Ecosystems of Southern Lao PDR


REF. NO.	DESCRIPTION	DATE	SIGNATURE	NAME	DATE	DRAWING TITLE	DRAWING NO.
1	DEPARTMENT OF AGRICULTURE AND FORESTRY (MAF)					GROUND BEAM PLAN	15
2	FOR						
3	FOREST RESOURCES MANAGEMENT (DFRM)						
4							
5							
6							
100							

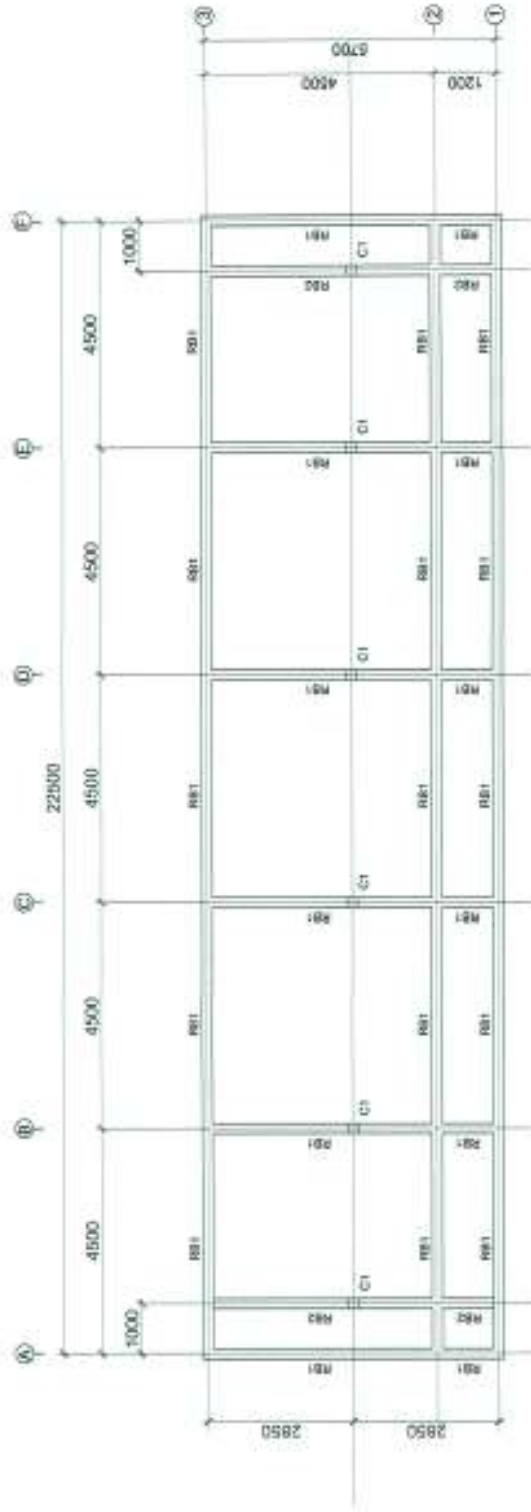

Symbol	
F1	1000x1000mm
F2	1150x1150mm
F3	800x800mm
C1	200x200mm
C2	200x200mm
C3	200x200mm
C100	200x200mm

ROOF BEAM PLAN 1:100





MINISTRY OF AGRICULTURE AND FORESTRY (MAF)				Sustainable Forest and Land Management in the Dry Dipterocarp Forest Ecosystems of Southern Lao PDR			
DEPARTMENT FOR FOREST RESOURCES MANAGEMENT (DFRM)				DRAWING TITLE			
				DATE			
				SIGNATURE			
				NAME			
				DESIGNED BY			
				CHECKED BY			
				APPROVED BY			
				DRAWING NO.			
				SCALE			
				DRAWING AT VISIT CENTER			
				ROOF BEAM PLAN			

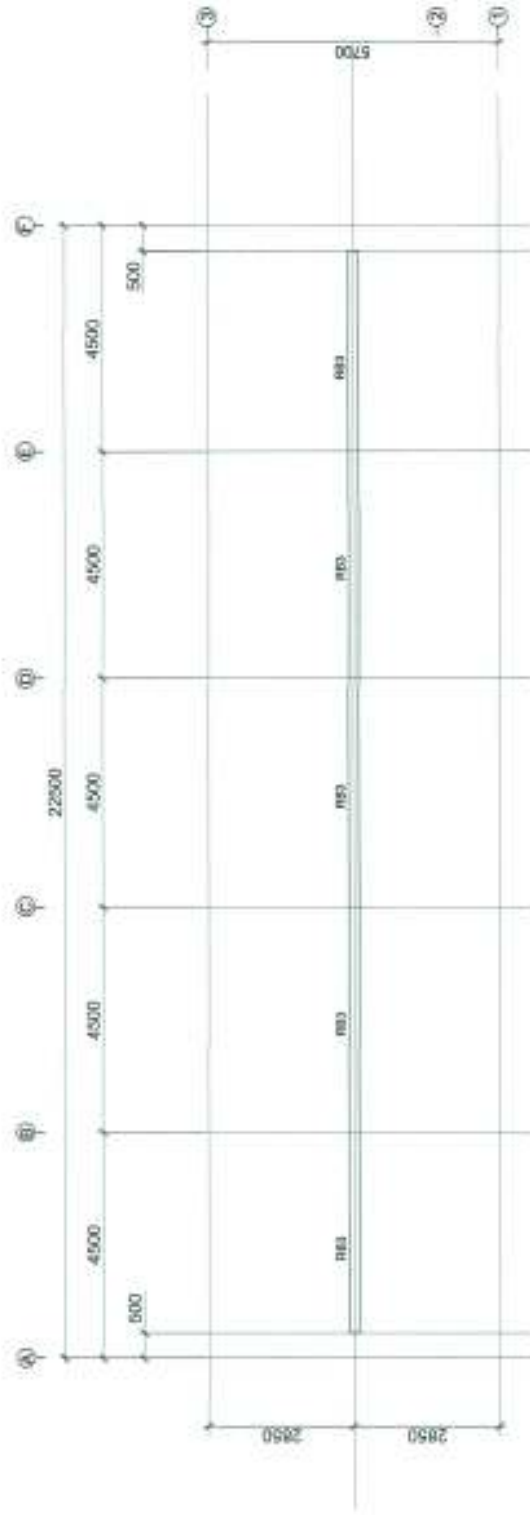

Symbol	Meaning
RB1	1900x1800mm
RB2	1900x1150mm
RB3	1900x1800mm
CL	2000x300mm
GB1	2000x300mm
GB2	2000x300mm
GB3	2000x300mm
GB100	2000x300mm

RIDGE BEAM PLAN 1:100

MINISTRY OF AGRICULTURE AND FORESTRY (MAF) DEPARTMENT FOR FOREST RESOURCES MANAGEMENT (DFRM)	Sustainable Forest and Land Management in the Dry Dipterocarp Forest Ecosystems of Southern Lao PDR					
	REV. No.	DESCRIPTION	DATE	DESIGNED BY	NAME	DRAWING TITLE
				CHECKED BY		ORATORY AT VERT CENTER
				APPROVED BY		SCALE
						1:100

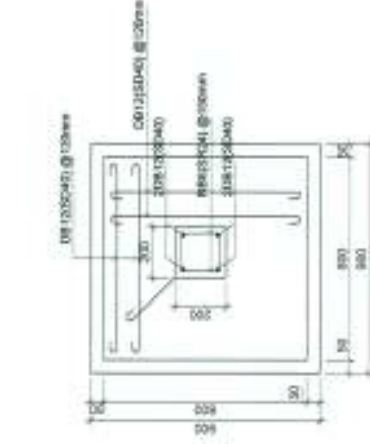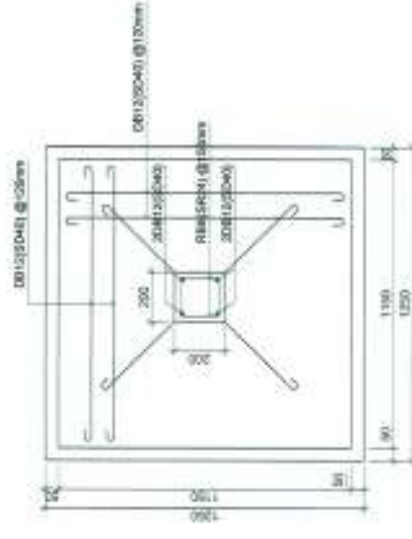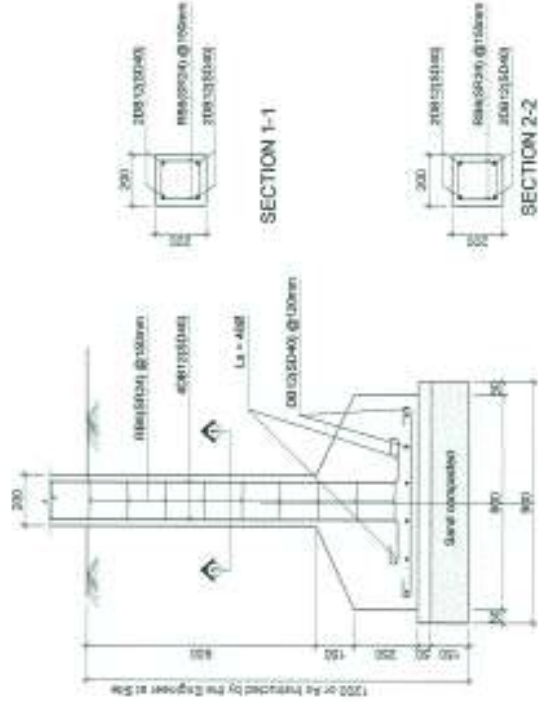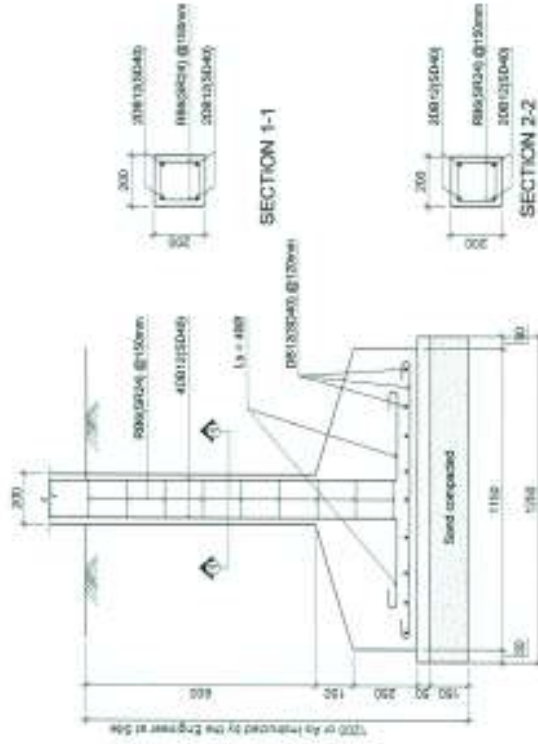

R.C FOOTING (F2)

R.C FOOTING (F3)

R.C FOOTING DETAIL


SCALE: 1/20

MINISTRY OF AGRICULTURE AND FORESTRY (MAF)

DEPARTMENT
FOR
FOREST RESOURCES MANAGEMENT (DFRM)

Sustainable Forest and Land Management in the Dry Dipterocarp Forest Ecosystems of Southern Lao PDR





REV. NO.	DESCRIPTION	DATE	DESIGNED BY	CHECKED BY	APPROVED BY	SIGNATURE	DATE	DRAWING TITLE	ISSUING NO.
								DORMITORY AT VISIT CENTER R.C FOOTING DETAIL	SCALE

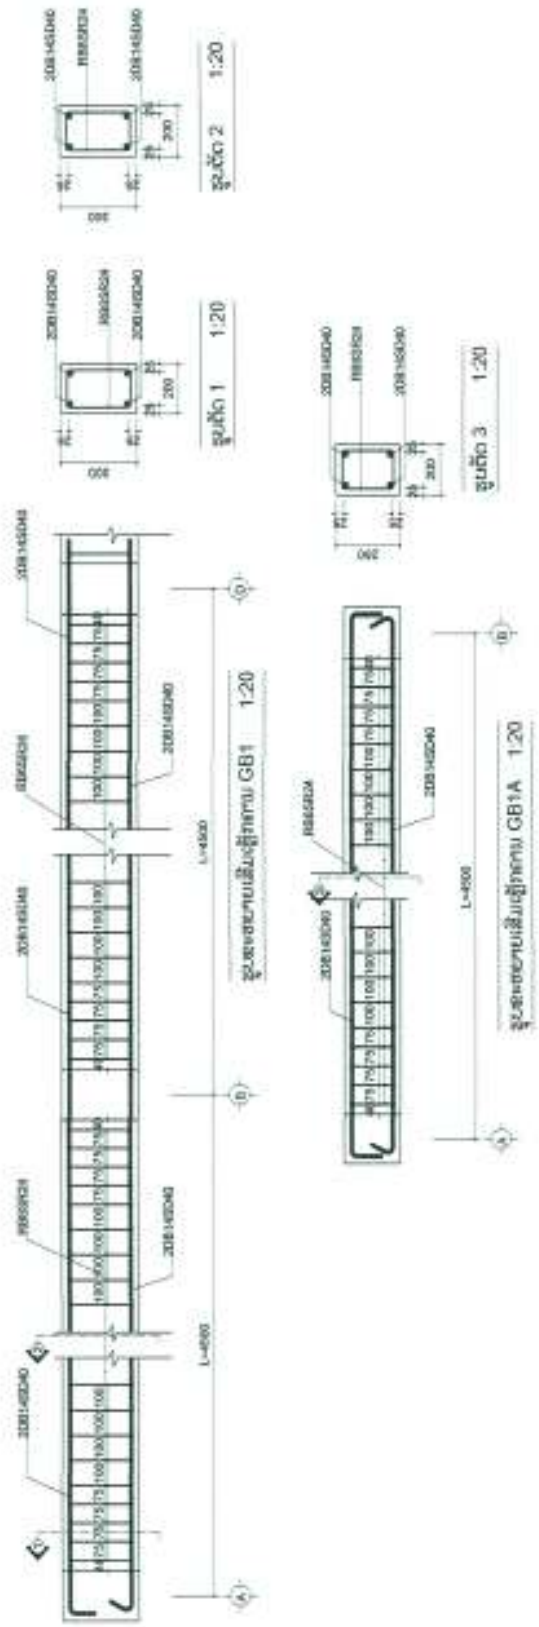

R.C GROUND BEAM DETAIL

SCALE: 1/20



MINISTRY OF AGRICULTURE AND FORESTRY (MAF)				Sustainable Forest and Land Management in the Dry Dipterocarp Forest Ecosystems of Southern Lao PDR								
DEPARTMENT FOR FOREST RESOURCES MANAGEMENT (DFRM)				REV. NO.	DESCRIPTION	DATE	DESIGNED BY	NAME	SIGNATURE	DATE	DRAWING TITLE	DRAWING NO.
							CHECKED BY					SCALE
							APPROVED BY					

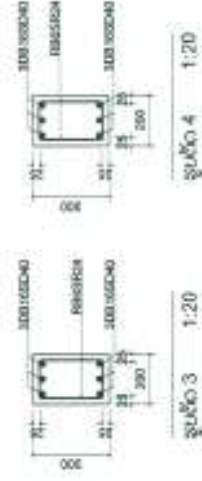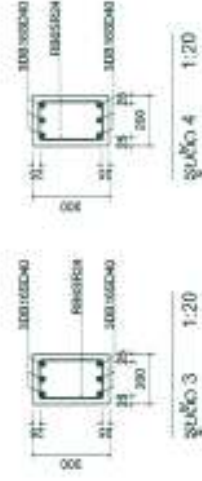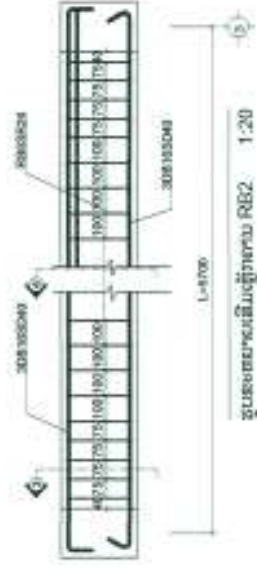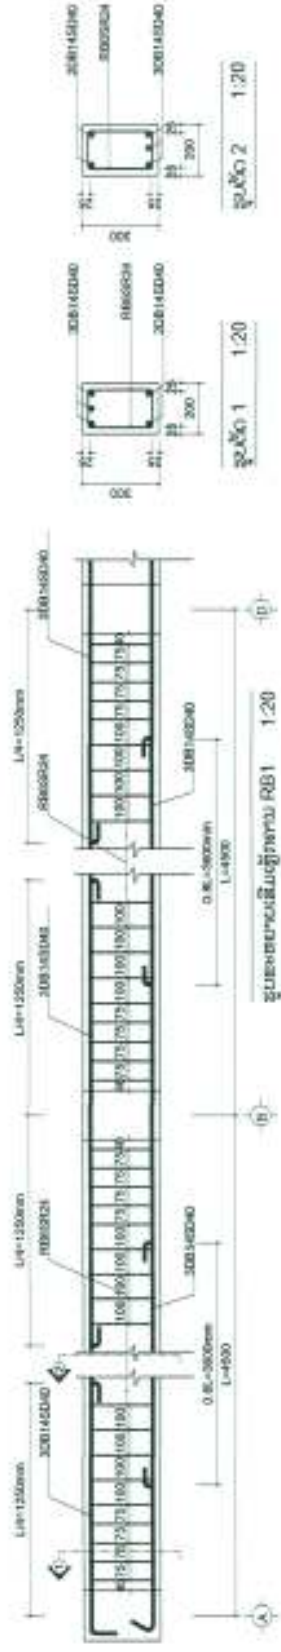

R.C ROOF BEAM DETAIL

SCALE: 1/20

MINISTRY OF AGRICULTURE AND FORESTRY (MAF) FOR FOREST RESOURCES MANAGEMENT (DFRM)	Sustainable Forest and Land Management in the Dry Dipterocarp Forest Ecosystems of Southern Lao PDR				
	REV. NO.	DESCRIPTION	DATE	DESIGNED BY	DRAWING NO.
				CHECKED BY	21
				APPROVED BY	SCALE
					DOSSATORY AT VIST CENTER
					R.C ROOF BEAM DETAIL

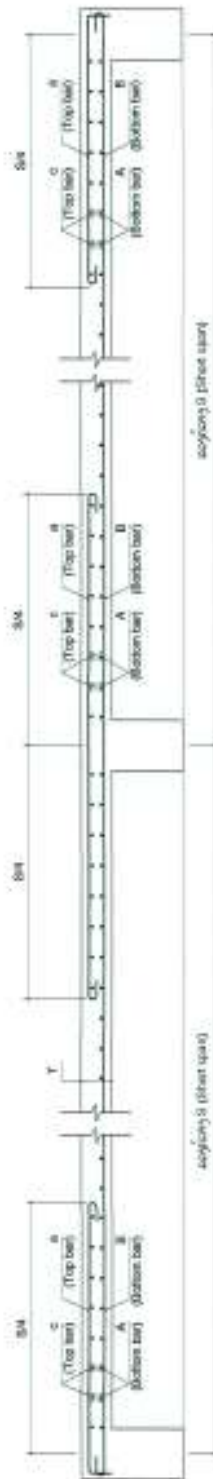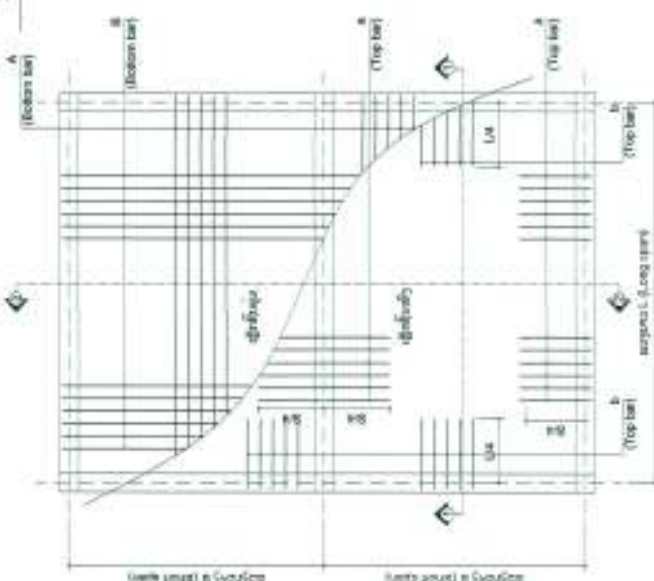[illegible]


ຕາຕະລາງການັດ, ເລຂາ ແລະ ຈຳເພີກ

ຂະໜາດເພີກ ສັນຍາລັກ	RB6	DB10	DB12	DB14	DB16
	a=24mm	a=40mm	a=48mm	a=56mm	a=64mm
	b=36mm	b=60mm	b=72mm	b=84mm	b=96mm
	c=72mm	c=120mm	c=144mm	c=168mm	c=192mm
	d=360mm	d=600mm	d=720mm	d=840mm	d=960mm
	e=240mm	e=400mm	e=480mm	e=560mm	e=640mm

Notes : Unless Otherwise Shown The Following Be Applies :

1. All Structural Concrete Shall Have 28 Days Compressive Strength of 25 KN (250 KSC)
2. The Yield Strength of the Main Reinforcement Steel Shall Be At Least 400 KN (4000KSC)
3. The Yield Strength of the Secondary Reinforcement Steel Shall Be At Least 240 KN (2400 KSC)

MINISTRY OF AGRICULTURE AND FORESTRY (MAF) DEPARTMENT FOR FOREST RESOURCES MANAGEMENT (DFRM)	Sustainable Forest and Land Management in the Dry Dipterocarp Forest Ecosystems of Southern Lao PDR									
	REV. NO.	DESCRIPTION	DATE	DESIGNED BY	NAME	SIGNATURE	DATE	DRAWING NO.	28	
				CHECKED BY						
				APPROVED BY						
								DOMESTICITY AT VAST CENTER REINFORCEMENT STEEL WINING		

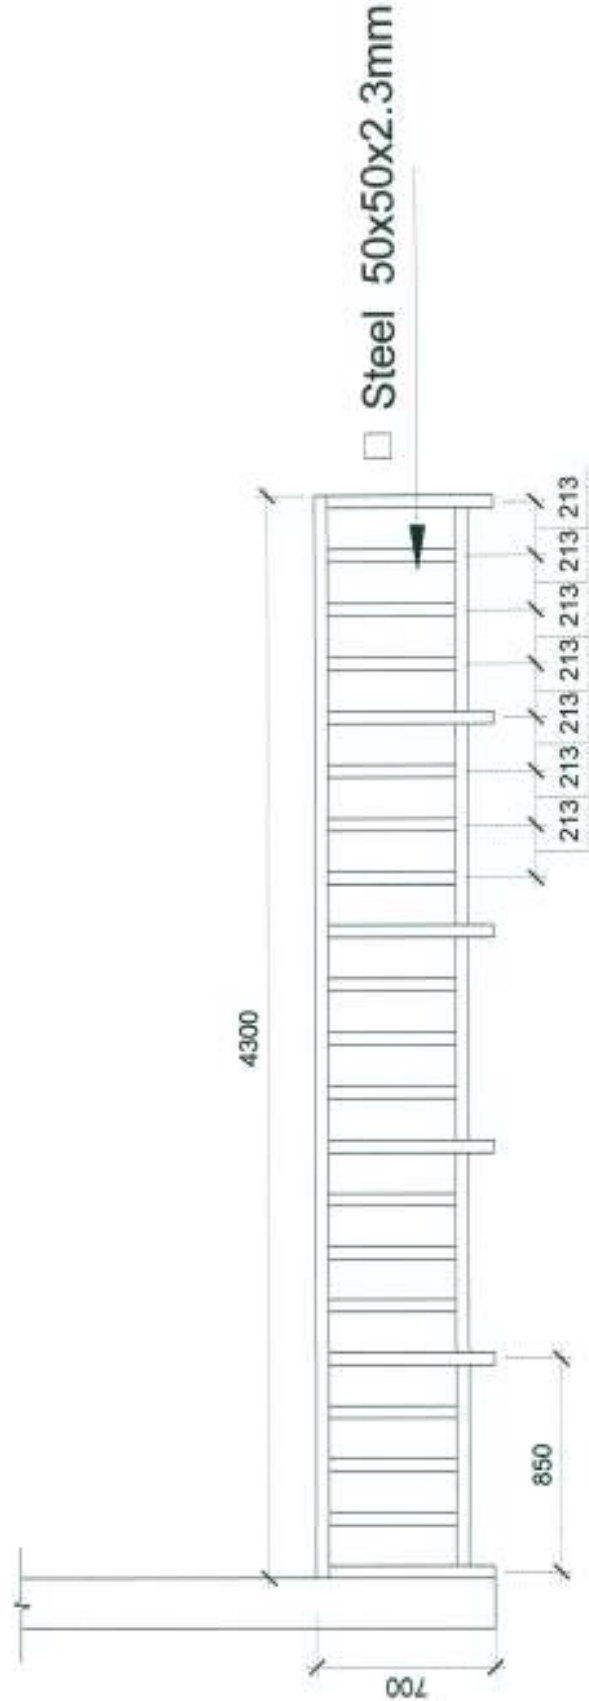

RAILING OF CORRIDOR

SCALE: 1/20

MINISTRY OF AGRICULTURE AND FORESTRY (MAF) DEPARTMENT FOR FOREST RESOURCES MANAGEMENT (DFRM)	Sustainable Forest and Land Management in the Dry Dipterocarp Forest Ecosystems of Southern Lao PDR							DRAWING NO.	25
	DESCRIPTION		DATE	DRAWN BY	CHECKED BY	DATE	DRAWING TITLE	DORMITORY AT VISIT CENTER	
	RAILING OF CORRIDOR							SCALE	

