



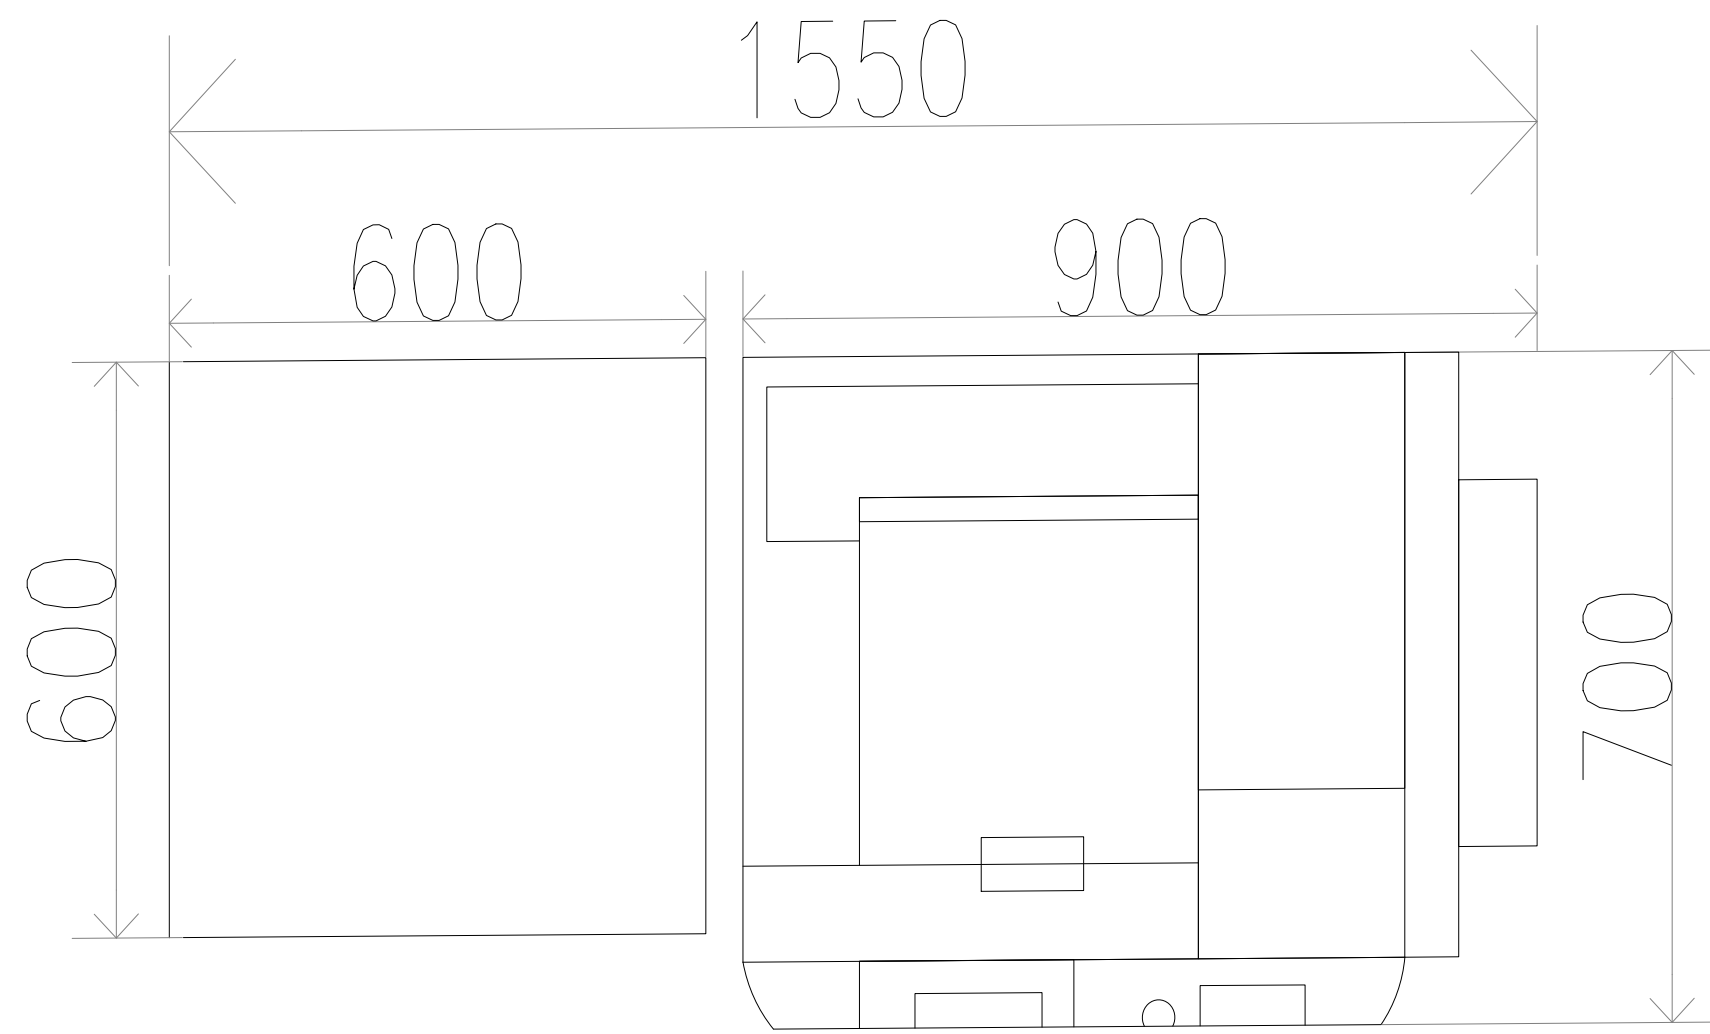


Top View

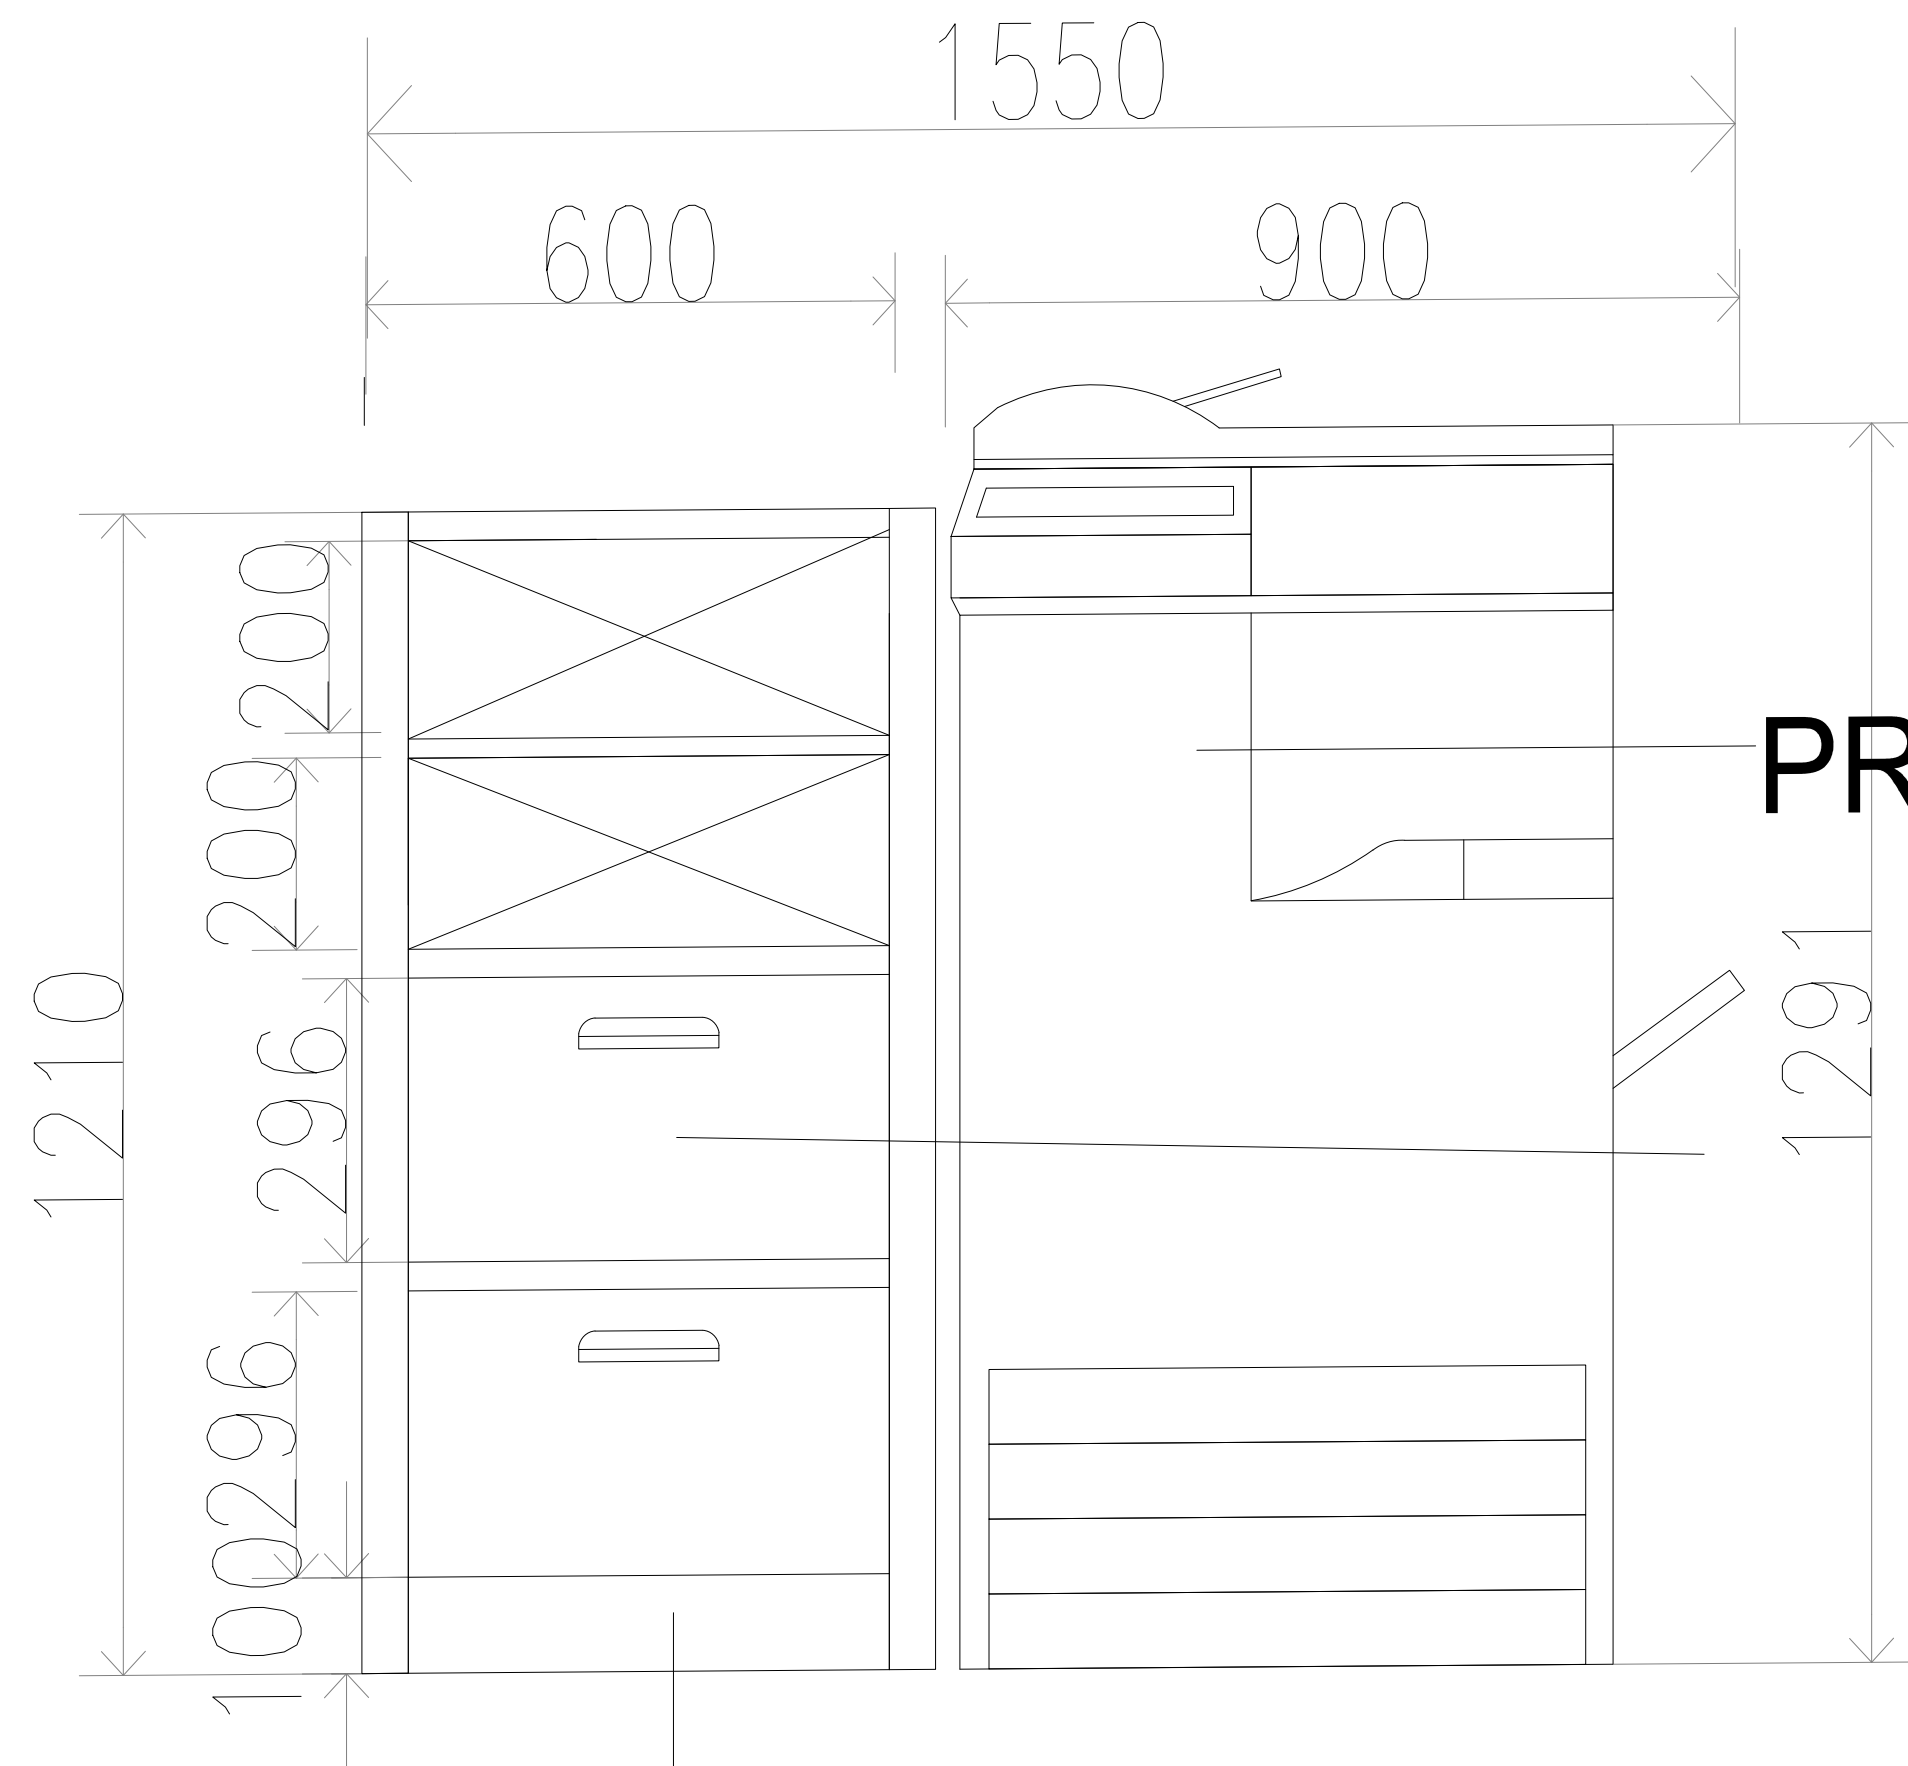

MAICA LAMINATE DIAMOND
COLLECTION M32400
LUMINOUS ASH

Front View

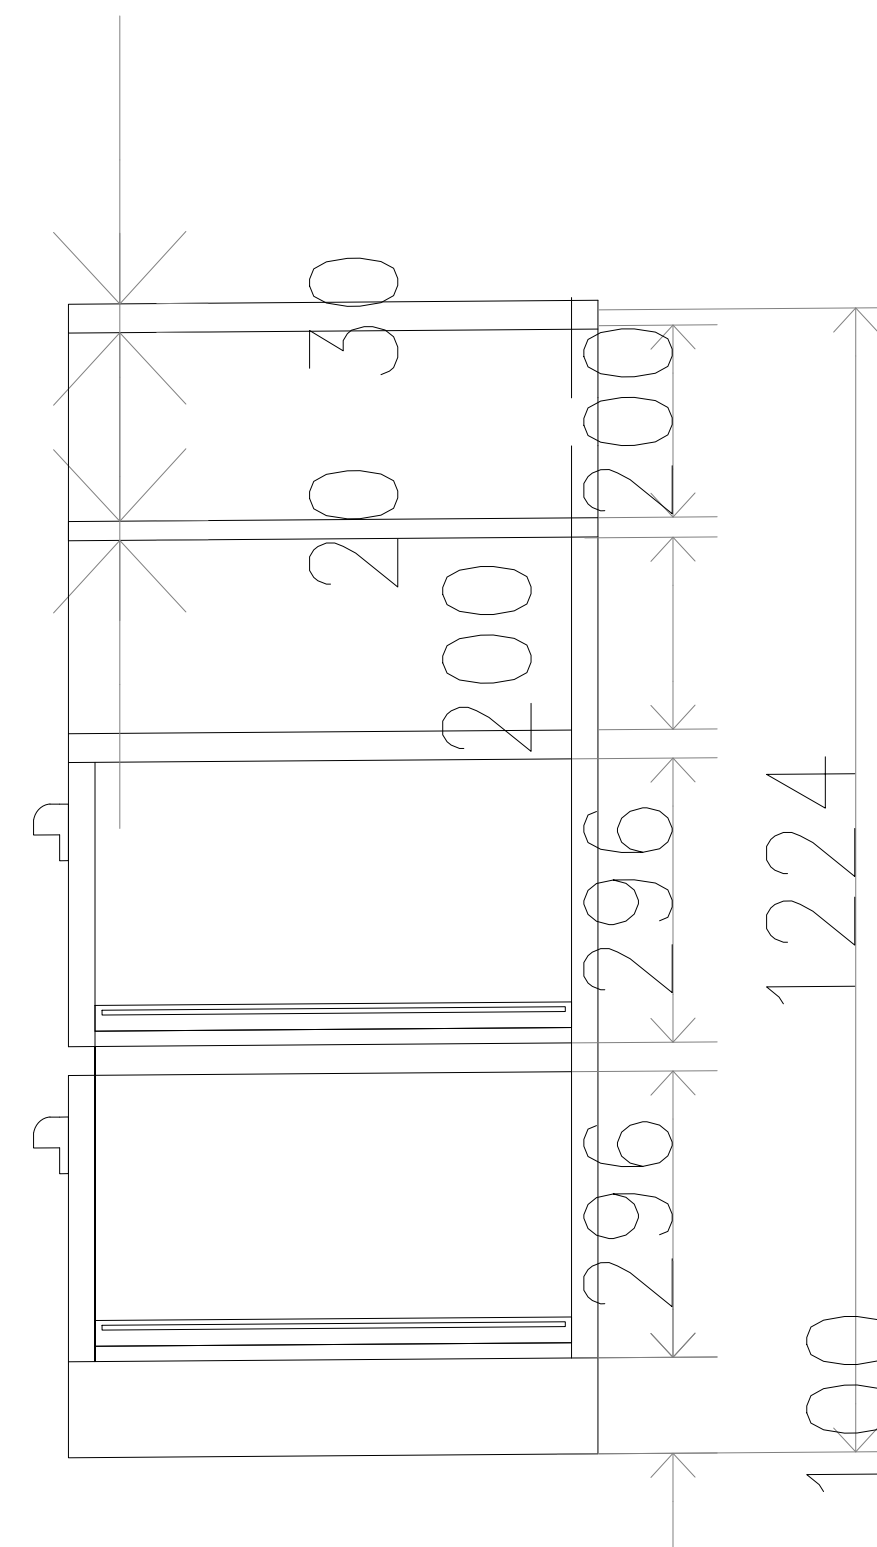

Side View

P1

Client / Developer :



PUTRAJAYA HOLDINGS
PUTRAJAYA HOLDINGS SDN. BHD (co.No.364152-K)
BLOK 1, MENARA SERI WILAYAH, PRECINCT 2
62100 PUTRAJAYA
TEL : 03-8883 8888 FAX : 03-8889 5499

Design & Built Contractor :




SPACE SCAPE

CONTRACTORS IN-HOUSE CONSULTANT :

Architect :

 Civil & Structure Engineer :



PERUNDING AZIZ, AZALI & TEE SDN. BHD.
NO. 2, JALAN KENARI 2
SEKSYEN 10, WILAYAH PERSEKUTUAN
62100 PUTRAJAYA
TEL : 03-8883 2482 / 7385
FAX : 03-8889 4994

Mechanical & Electrical Engineer :



PERLINDING UNIREKA
NO. 1, JALAN 18
SEKSYEN 10, WILAYAH PERSEKUTUAN
62100 PUTRAJAYA
TEL : 03-8883 2482 / 7385
FAX : 03-8889 4994
E-MAIL : unireka@unireka.com

Landscape Architect :



VERITAS LANDSCAPE SDN BHD
SUITE 115, BLOK 8, MEGA KAWAN 2
JALAN KAWAN 2, WILAYAH PERSEKUTUAN
62100 PUTRAJAYA
TEL : 03-8883 2482 / 7385
FAX : 03-8889 4994
E-MAIL : veritas@veritas.com

Facade Consultant :



Aurecon Singapore (Pte.) Ltd.
100 ROBINSON ROAD
SINGAPORE 068902
TEL : 65-6733 1550
FAX : 65-6733 1551
E-MAIL : singapore@aurecongroup.com

Quantity Surveyor :



KPK QUANTITY SURVEYORS (SEMANANG) SDN BHD
110-112, BLOK B, TINGKAT 1100, MEGA
KAWAN 2, WILAYAH PERSEKUTUAN
62100 PUTRAJAYA
TEL : 03-8883 2482 / 7385
FAX : 03-8889 4994

Green Building Consultant :



Exergy Malaysia Sdn Bhd
19B & 21B, JALAN 17 / 45, 46400 PETALING JAYA
SEKSYEN 17, PETALING JAYA
TEL : 603 79583655 FAX : 603 79563660

Project Title :

**CADANGAN UBAHSUAI
TEMPAT KERJA JABAT
MENARA PJH TINGKAT 10
PEMBANGUNAN 3 BLOK**

UNTUK:
UNITED NATIONS MALAYSIA

Drawing Title :

FURNITURE P1 DETAIL

Electrical Contractor :



OMEGA ELECTRICAL
10, JALAN 18
SEKSYEN 10, WILAYAH PERSEKUTUAN
62100 PUTRAJAYA
TEL : 03-8883 2482 / 7385
FAX : 03-8889 4994
E-MAIL : omega@omega.com

Signature of Client / Developer :

Signature of M&E :

Contract No. :


No. Lukisan :

Drawings No. :


Amendments

Revision No.	Date	Notes	Status


P2

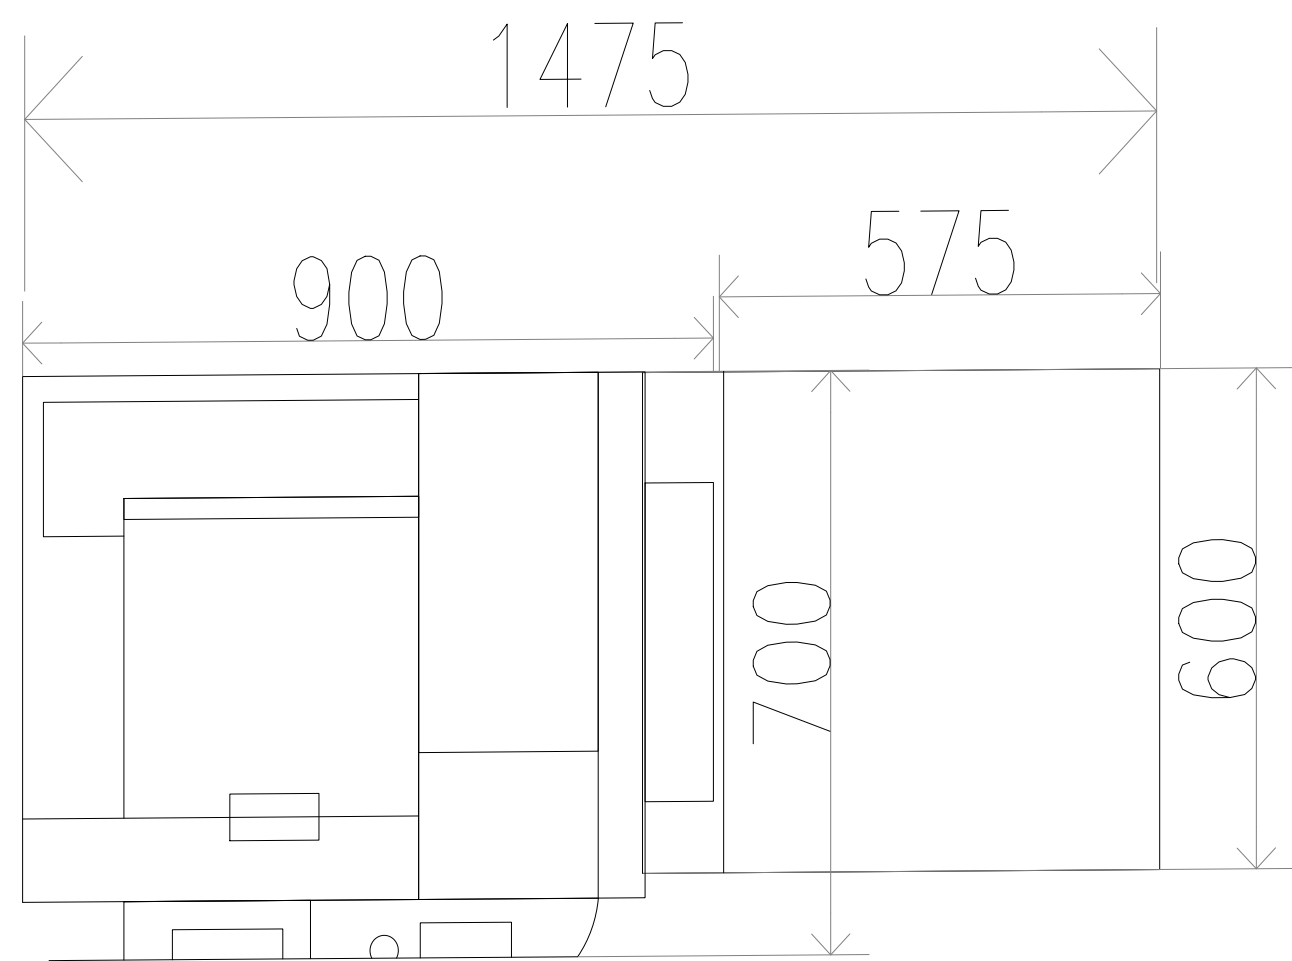





Top View

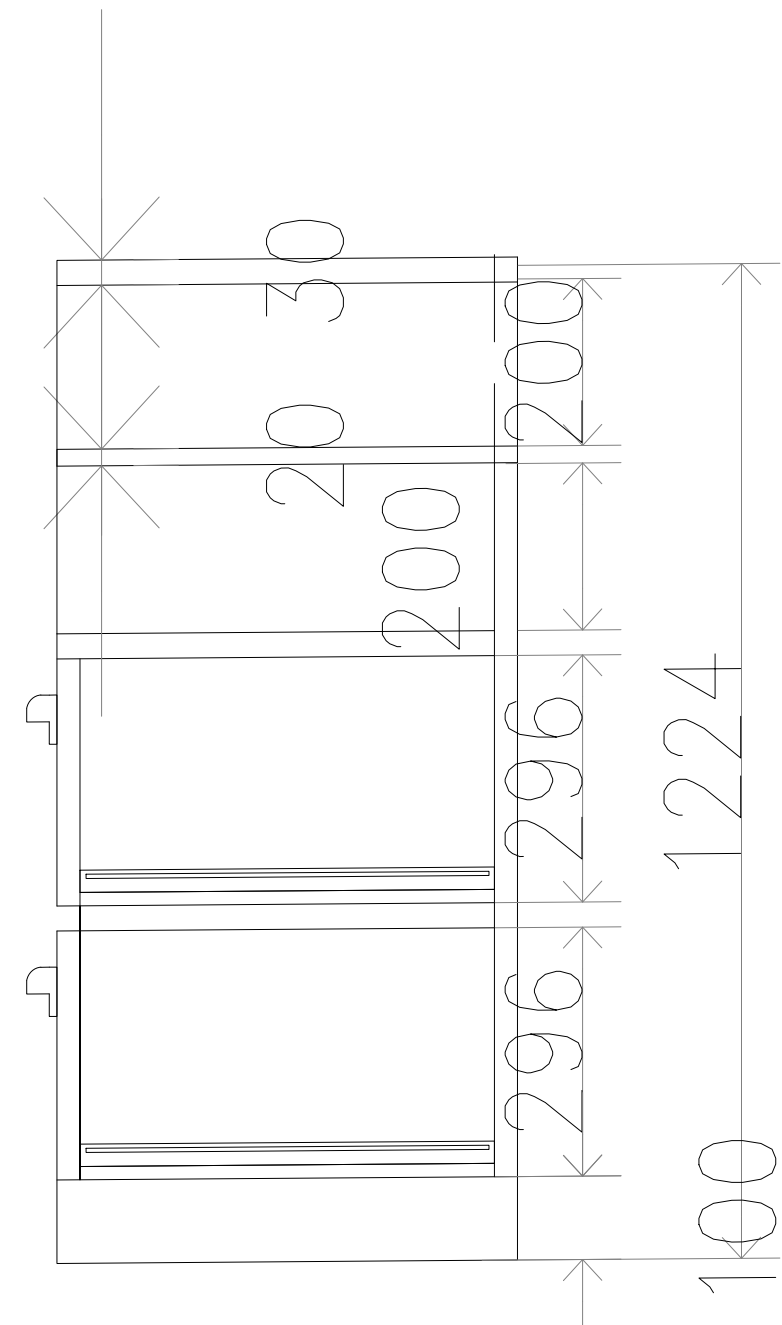


Side View

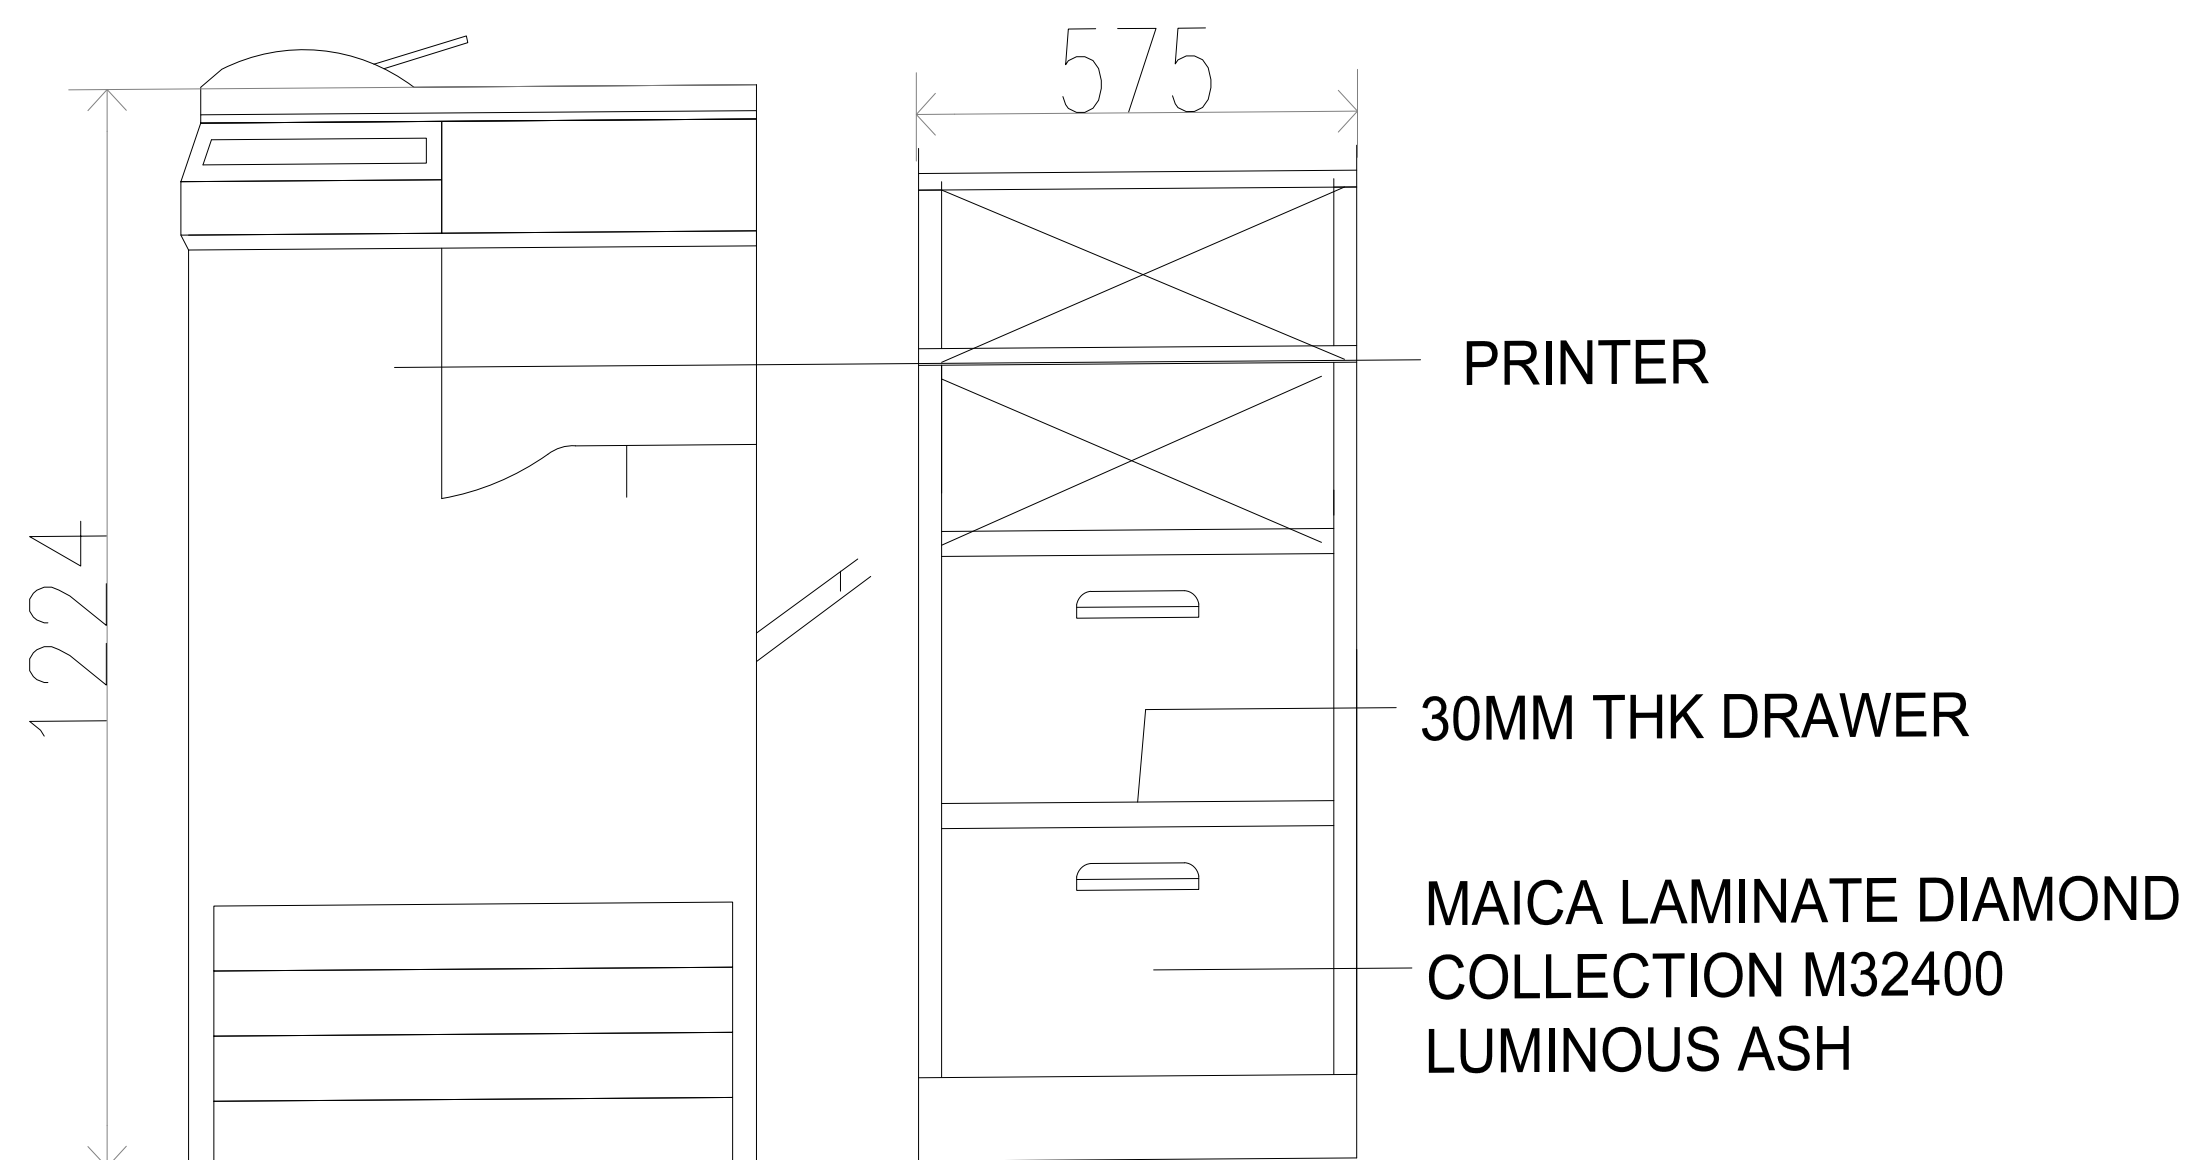


Front View

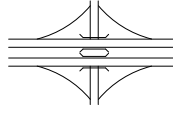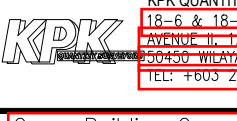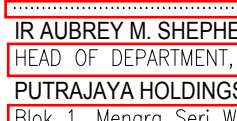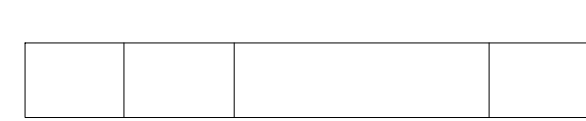Client / Developer :			
 PUTRAJAYA HOLDINGS PUTRAJAYA HOLDINGS SDN. BHD (co.No.364152-K) BLOK 1, MENARA SERI WILAYAH, PRECINCT 2 62100-PUTRAJAYA TEL : 03-8883 8888 FAX : 03-8889 5499			
Design & Built Contractor :			
 SPACE SCOPE			
CONTRACTORS IN-HOUSE CONSULTANT :			
Architect :			
Civil & Structure Engineer :			
 PERUNDING AZIZ, AZALI & TEE SDN. BHD. NO. 2, JALAN KEMER 2 SEKSYEN 10, WILAYAH PERSEKUTUAN 62100-PUTRAJAYA TEL : 03-8883 2482, 7385 FAX : 03-8889 4994			
Mechanical & Electrical Engineer :			
 PERLINDUNG UNIREKA NO. 1, JALAN 18 SEKSYEN 10, WILAYAH PERSEKUTUAN 62100-PUTRAJAYA TEL : 03-8883 2482, 7385 FAX : 03-8889 4994			
Landscape Architect :			
 VERITAS LANDSCAPE SDN BHD 15-15, BLOK 8, MEWAH KINER 15 SEKSYEN 10, WILAYAH PERSEKUTUAN 62100-PUTRAJAYA TEL : 03-8883 2482, 7385 FAX : 03-8889 4994			
Facade Consultant :			
 Aurecon Singapore (Pte.) Ltd. 15, 15, BLOK 8, MEWAH KINER 15 SEKSYEN 10, WILAYAH PERSEKUTUAN 62100-PUTRAJAYA TEL : 03-8883 2482, 7385 FAX : 03-8889 4994			
Quantity Surveyor :			
 KPK QUANTITY SURVEYORS (SEMANJANG) SDN BHD 15, 15, BLOK 8, MEWAH KINER 15 SEKSYEN 10, WILAYAH PERSEKUTUAN 62100-PUTRAJAYA TEL : 03-8883 2482, 7385 FAX : 03-8889 4994			
Green Building Consultant :			
 Exergy Malaysia Sdn Bhd 198 & 215, JALAN 17 / 45, 46400 PETALING JAYA SEKSYEN 10, WILAYAH PERSEKUTUAN TEL : 03-79583655 FAX : 03-79563660			
Project Title :			
CADANGAN UBAHSUAI TEMPAT KERJA JABAT MENARA PJH TINGKAT 10 PEMBANGUNAN 3 BLOK			
UNTUK: UNITED NATIONS MALAYSIA			
Drawing Title :			
FURNITURE P2 DETAIL			
Electrical Contractor :			
 OMEGA ELECTRICAL 15, 15, BLOK 8, MEWAH KINER 15 SEKSYEN 10, WILAYAH PERSEKUTUAN 62100-PUTRAJAYA TEL : 03-8883 2482, 7385 FAX : 03-8889 4994			
Signature of Client / Developer :			
 MR. AUBREY M. SHEPHERDSON HEAD OF DEPARTMENT, COMMERCIAL BUILDING PUTRAJAYA HOLDINGS SDN. BHD (co.No.364152-K) Blok 1, Menara Seri Wilayah, Precinct 2 62100-PUTRAJAYA Tel : 03-8883 8888 Fax : 03-8889 5499			
Signature of M&E :			
			
Contract No. :			
			
No. Lukisan :			
			
Drawings No. :			
			
Amendments			
Revision No.	Date	Notes	Status

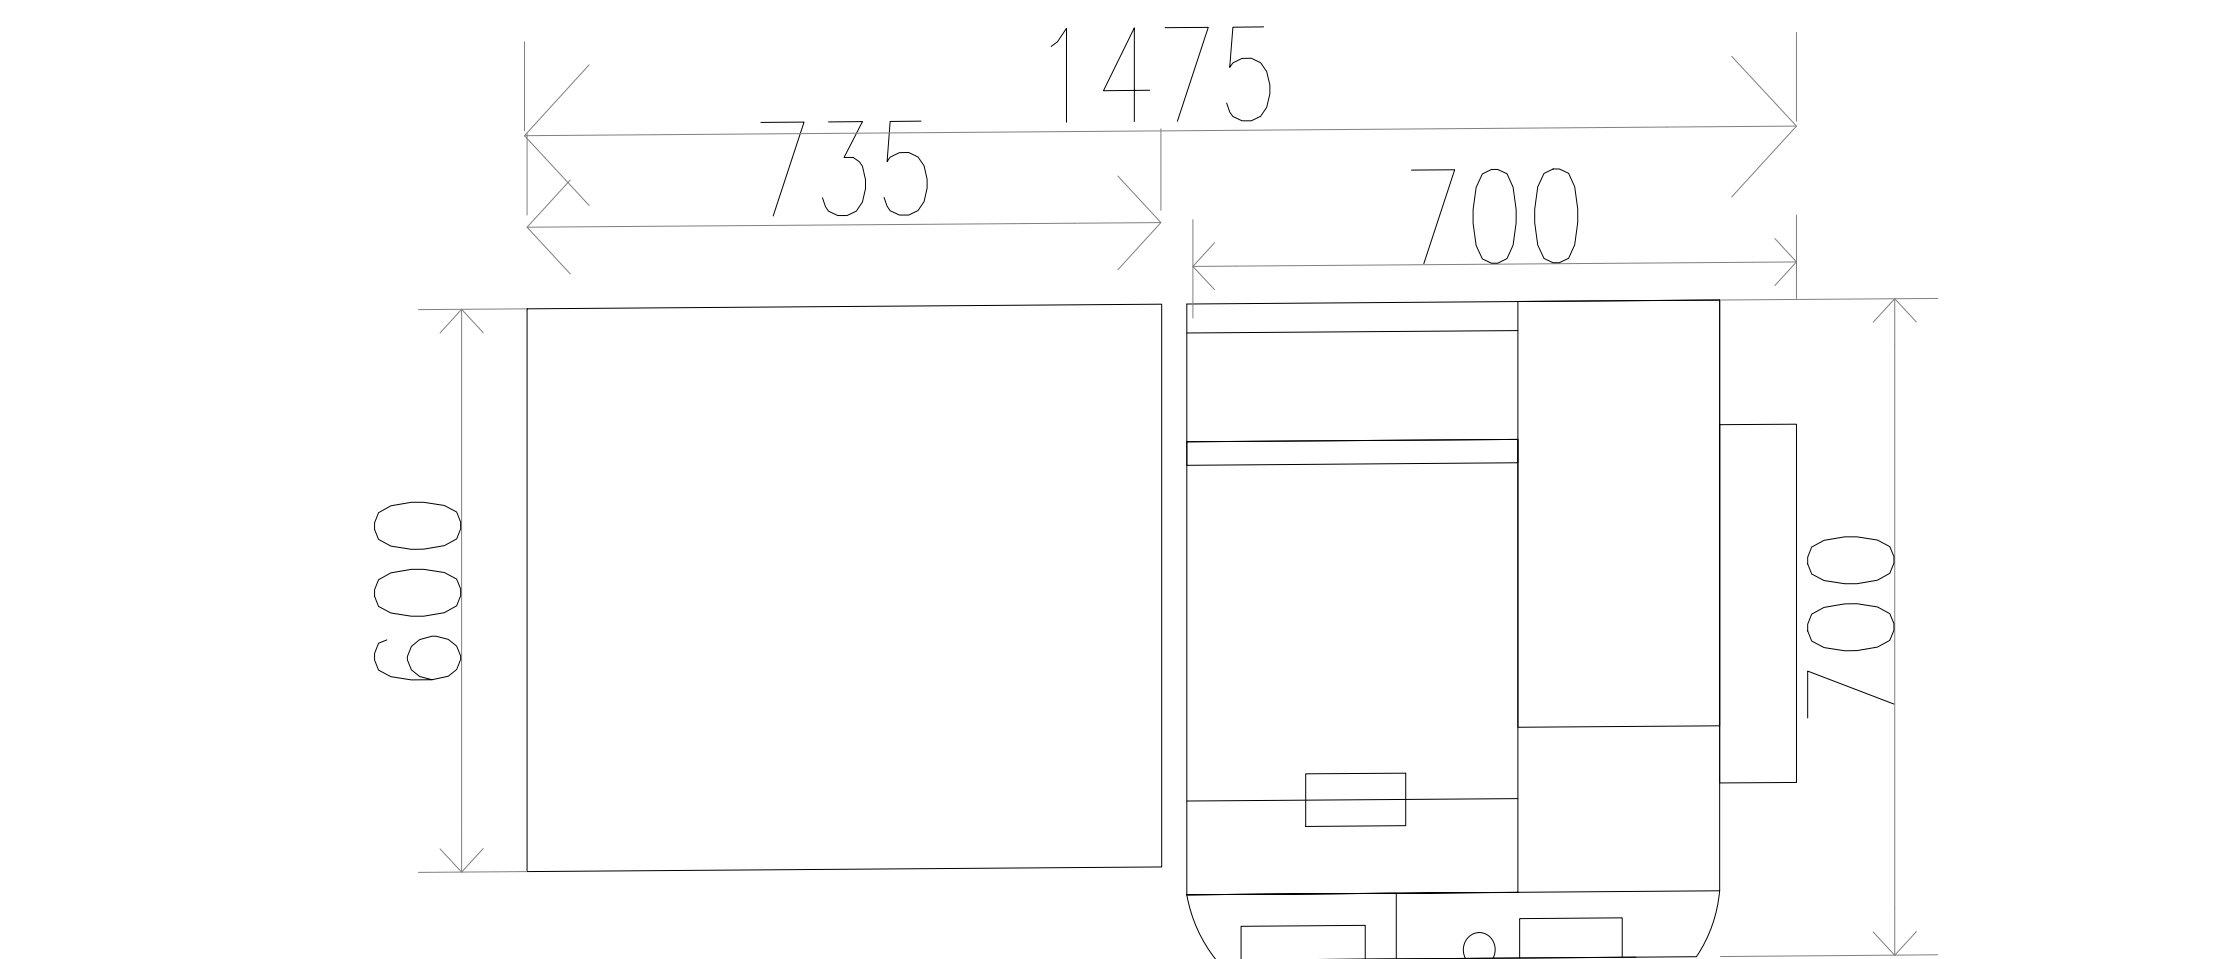

Top View

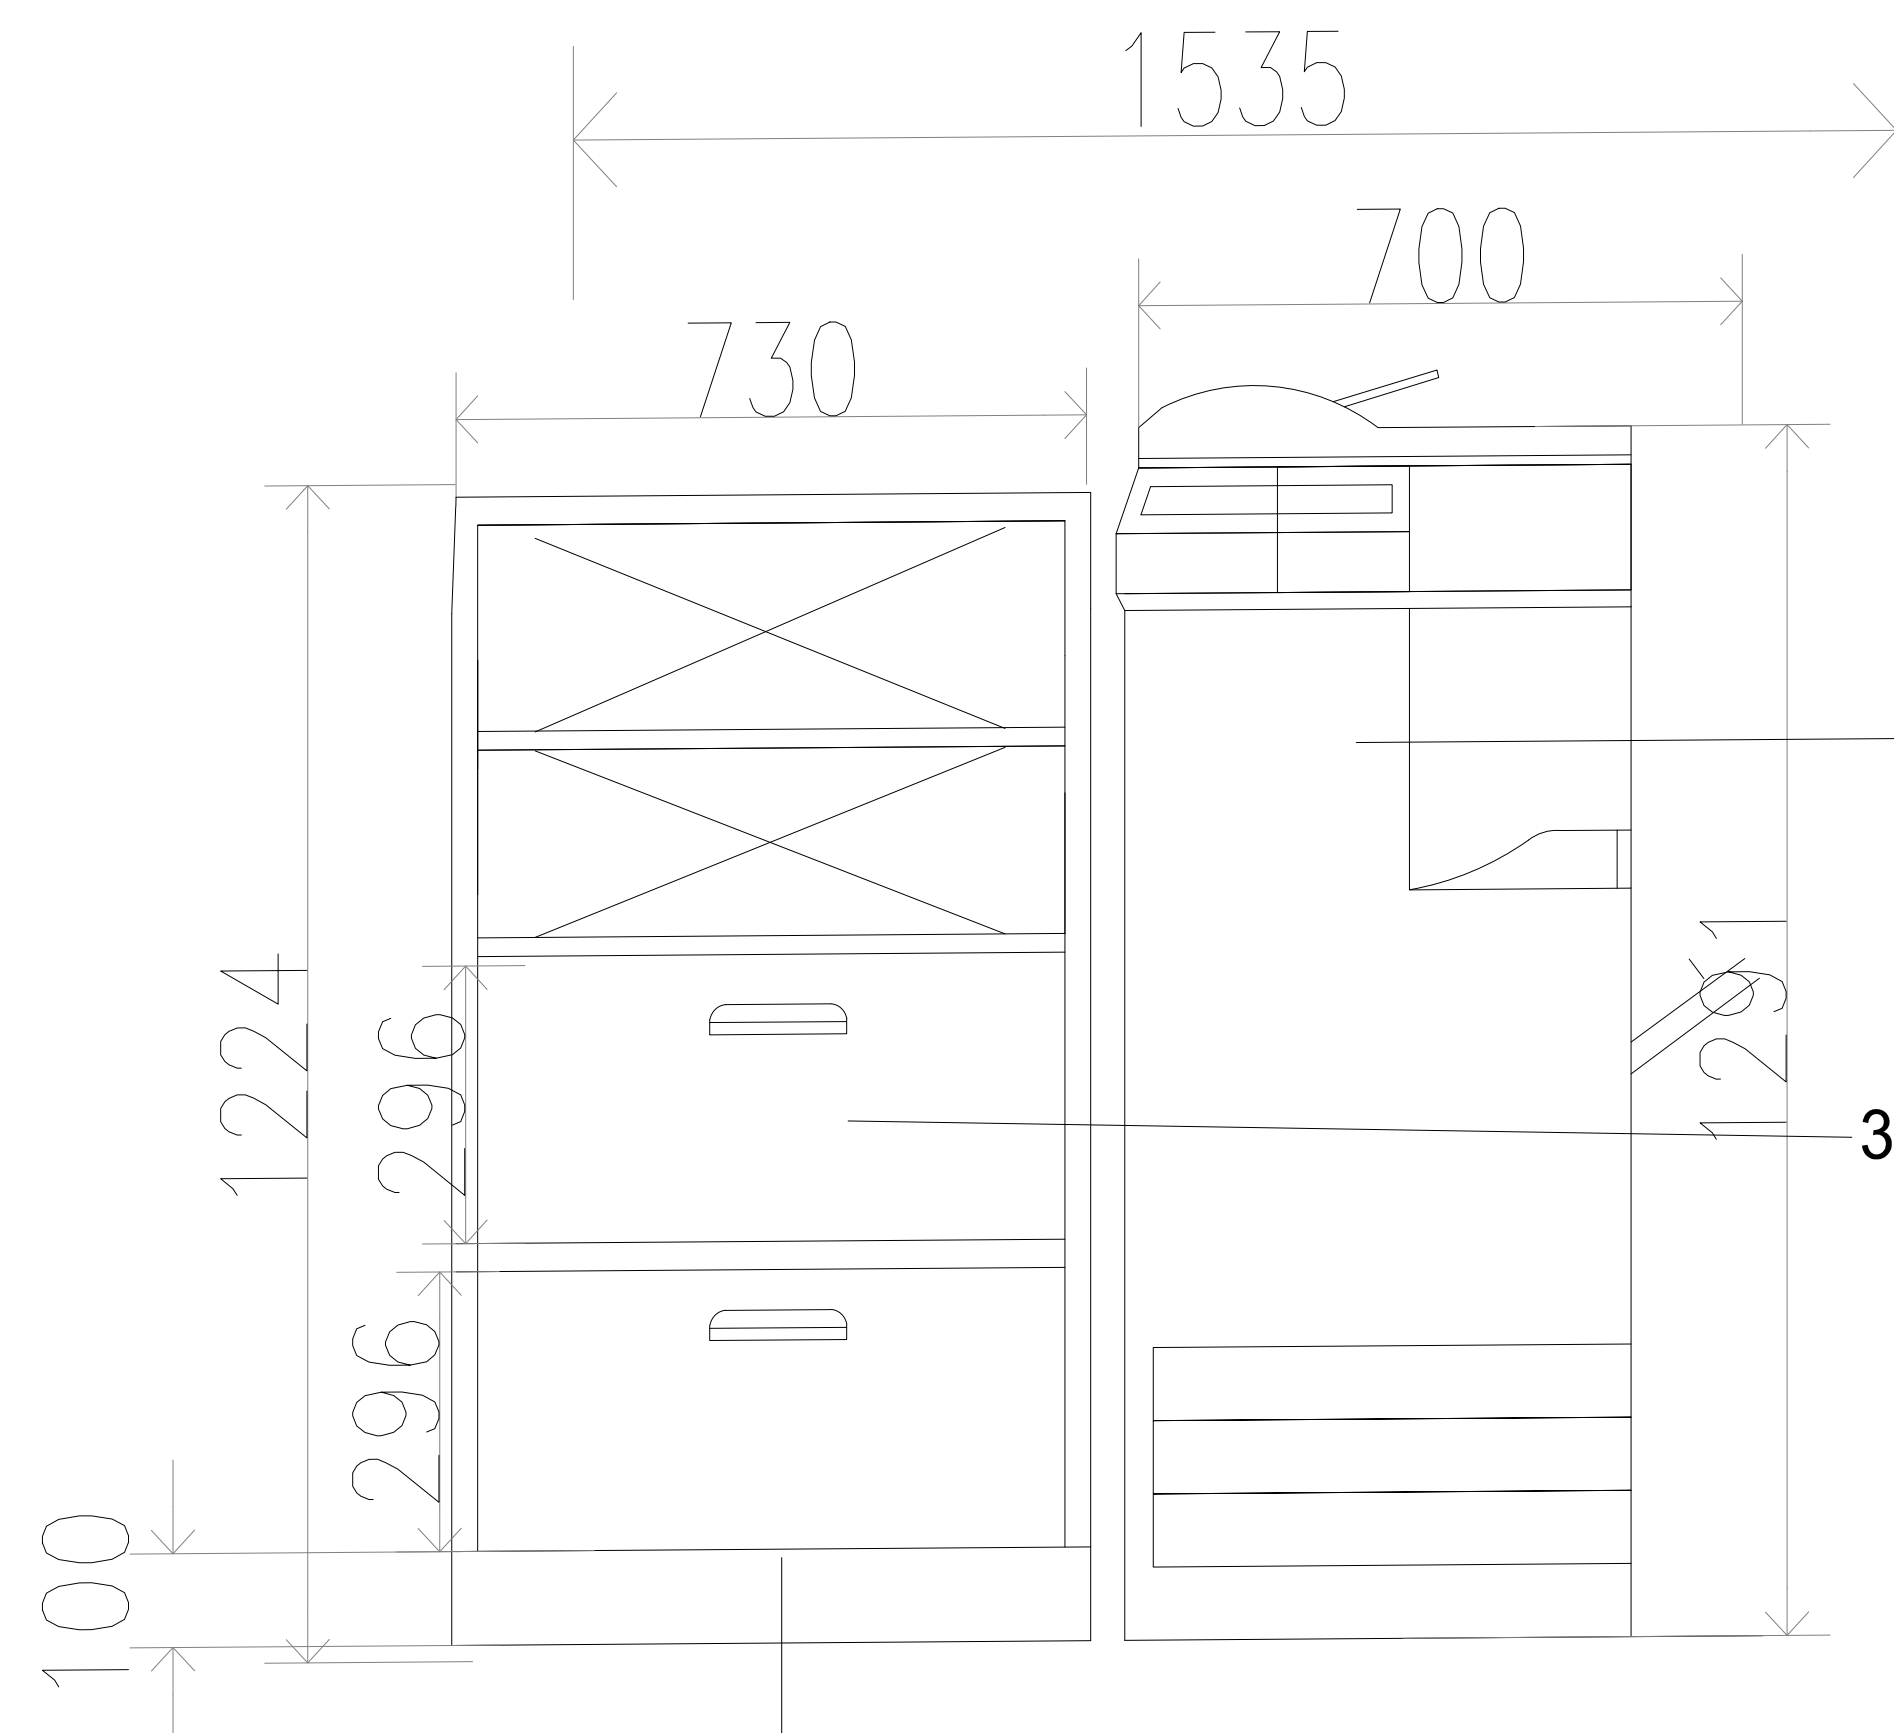


Front View

MAICA LAMINATE DIAMOND
COLLECTION M32400
LUMINOUS ASH



PRINTER


30MM THK DRAWER

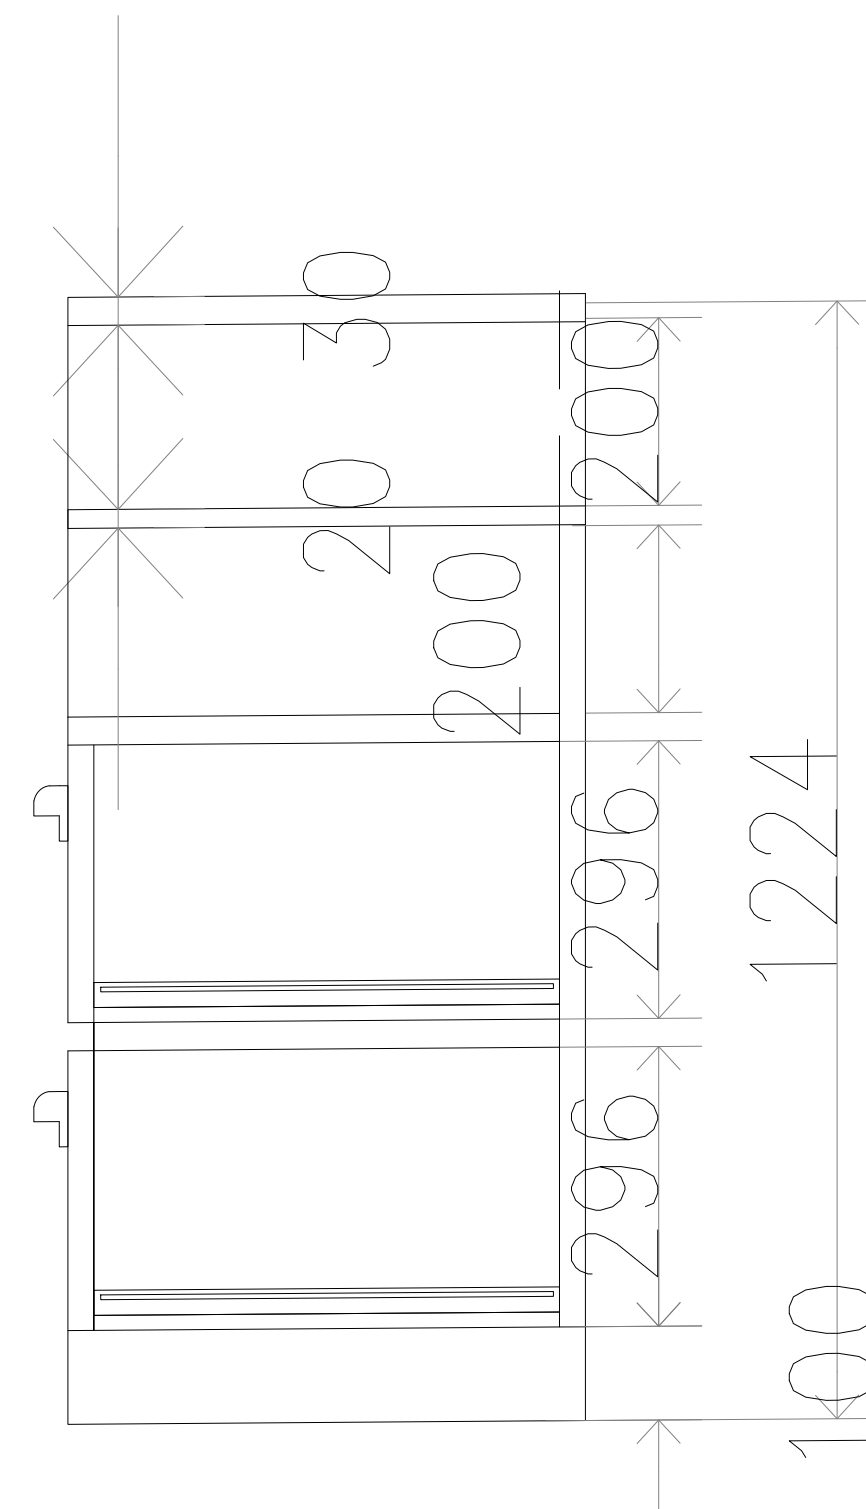


Side View

  P4

Client / Developer :			
 PUTRAJAYA HOLDINGS PUTRAJAYA HOLDINGS SDN. BHD (co.No.364152-K) BLOK 1, MENARA SERI WILAYAH, PRECINCT 2 62100 PUTRAJAYA TEL : 03-8883 8888 FAX : 03-8889 5499			
Design & Built Contractor :			
 SPACE SCAPE			
CONTRACTORS IN-HOUSE CONSULTANT :			
Architect :			
Civil & Structure Engineer :			
 PERUNDING AZIZ, AZALI & TEE SDN. BHD. NO. 2, JALAN KENARI 2 SEKSYEN 10, WILAYAH PERSEKUTUAN 62100 PUTRAJAYA TEL : 03-8883 2482, 7385 FAX : 03-8889 4994			
Mechanical & Electrical Engineer :			
 PERLINDING UNIREKA NO. 1, JALAN 18 SEKSYEN 10, WILAYAH PERSEKUTUAN 62100 PUTRAJAYA TEL : 03-8883 2482, 7385 FAX : 03-8889 4994			
Landscape Architect :			
 VERITAS LANDSCAPE SDN BHD 15, 17 & 19, BLOK 8, MEGA WILAYAH 62100 PUTRAJAYA TEL : 03-8883 2482, 7385 FAX : 03-8889 4994			
Facade Consultant :			
 Aurecon Singapore (Pte.) Ltd. 100, ROBINSON ROAD SINGAPORE 068917 TEL : 65-6733 6100 FAX : 65-6733 6101 E-MAIL : singapore@aurecongroup.com			
Quantity Surveyor :			
 KPK QUANTITY SURVEYORS (SEMANJANG) SDN BHD 110-112, BLOK 8, 11011 FLOOR, MEGA WILAYAH PERSEKUTUAN 62100 PUTRAJAYA TEL : 03-8883 2482, 7385 FAX : 03-8889 4994			
Green Building Consultant :			
 Exergy Malaysia Sdn Bhd 198 & 218, JALAN 17 / 45, 46400 PETALING JAYA SEKSYEN 17, PETALING JAYA TEL : 603 79583655 FAX : 603 79563660			
Project Title :			
CADANGAN UBAHSUAI TEMPAT KERJA JABAT MENARA PJH TINGKAT 10 PEMBANGUNAN 3 BLOK			
UNTUK: UNITED NATIONS MALAYSIA			
Drawing Title :			
FURNITURE P4 DETAIL			
Electrical Contractor :			
 OMEGA ELECTRICAL 10, JALAN 18 SEKSYEN 10, WILAYAH PERSEKUTUAN 62100 PUTRAJAYA TEL : 03-8883 2482, 7385 FAX : 03-8889 4994			
Signature of Client / Developer :			
IR AUBREY M. SHEPHERDSON HEAD OF DEPARTMENT, COMMERCIAL BUILDING PUTRAJAYA HOLDINGS SDN. BHD (co.No.364152-K) Blok 1, Menara Seri Wilayah, Precinct 2 62100 Putrajaya Tel : 03-8883 8888 Fax : 03-8889 5499			
Signature of M&E :			
Contract No. :			
No. Lukisan :			
Drawings No. :			
Amendments			
Revision No.	Date	Notes	Status

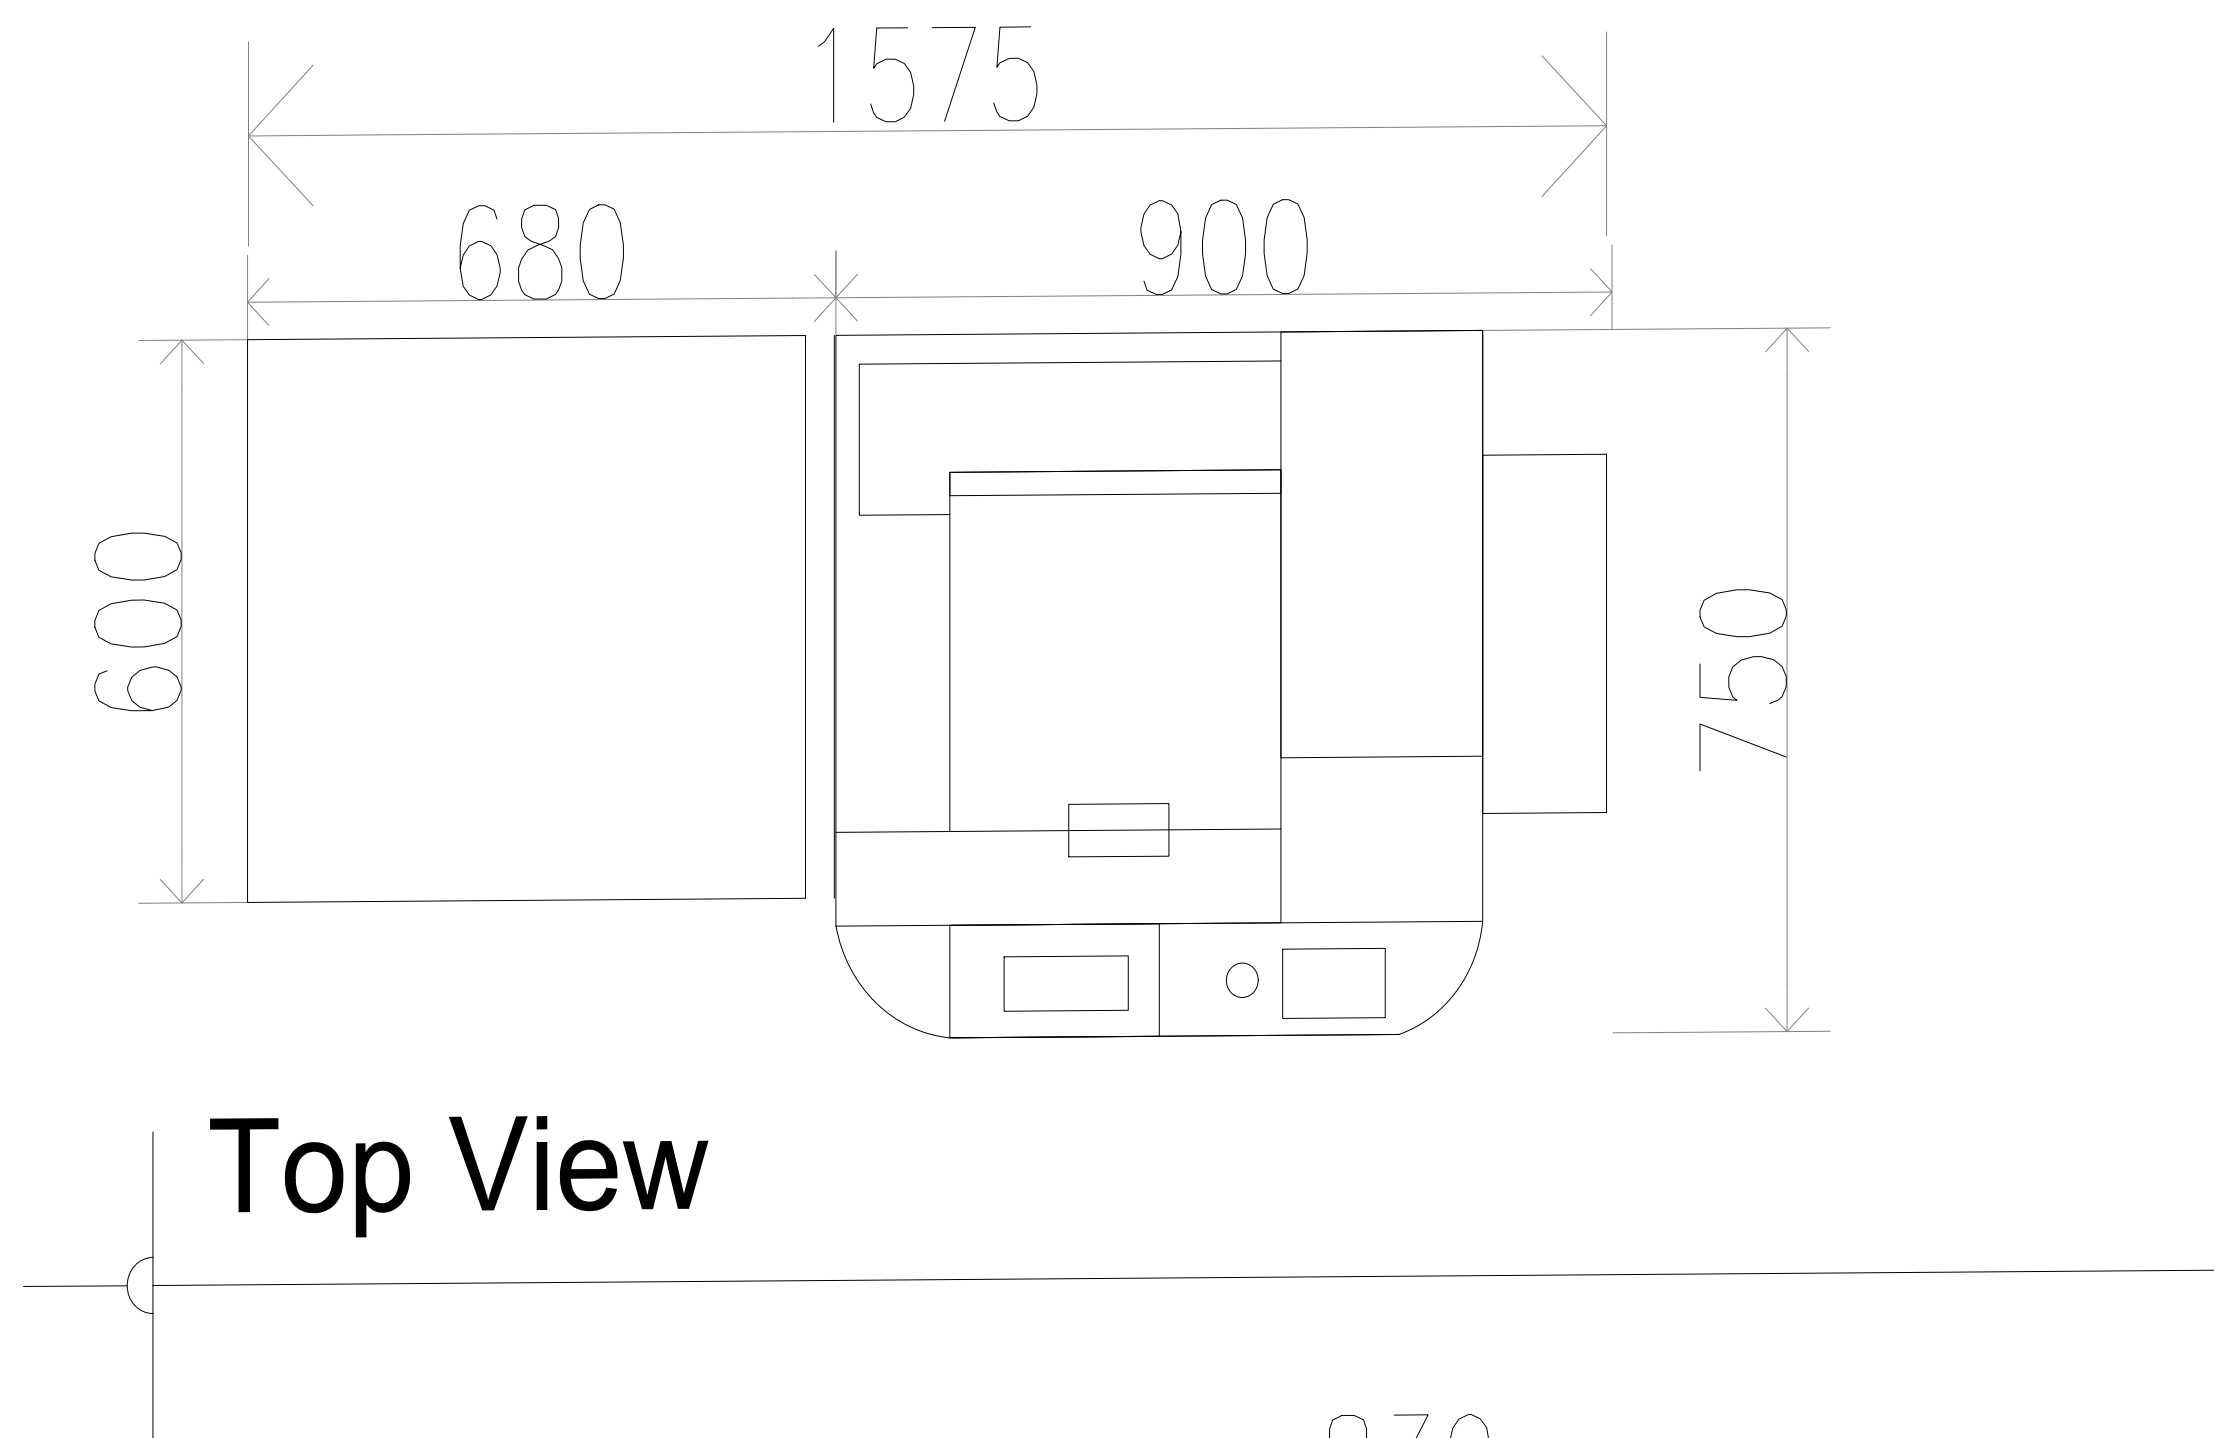


Top View

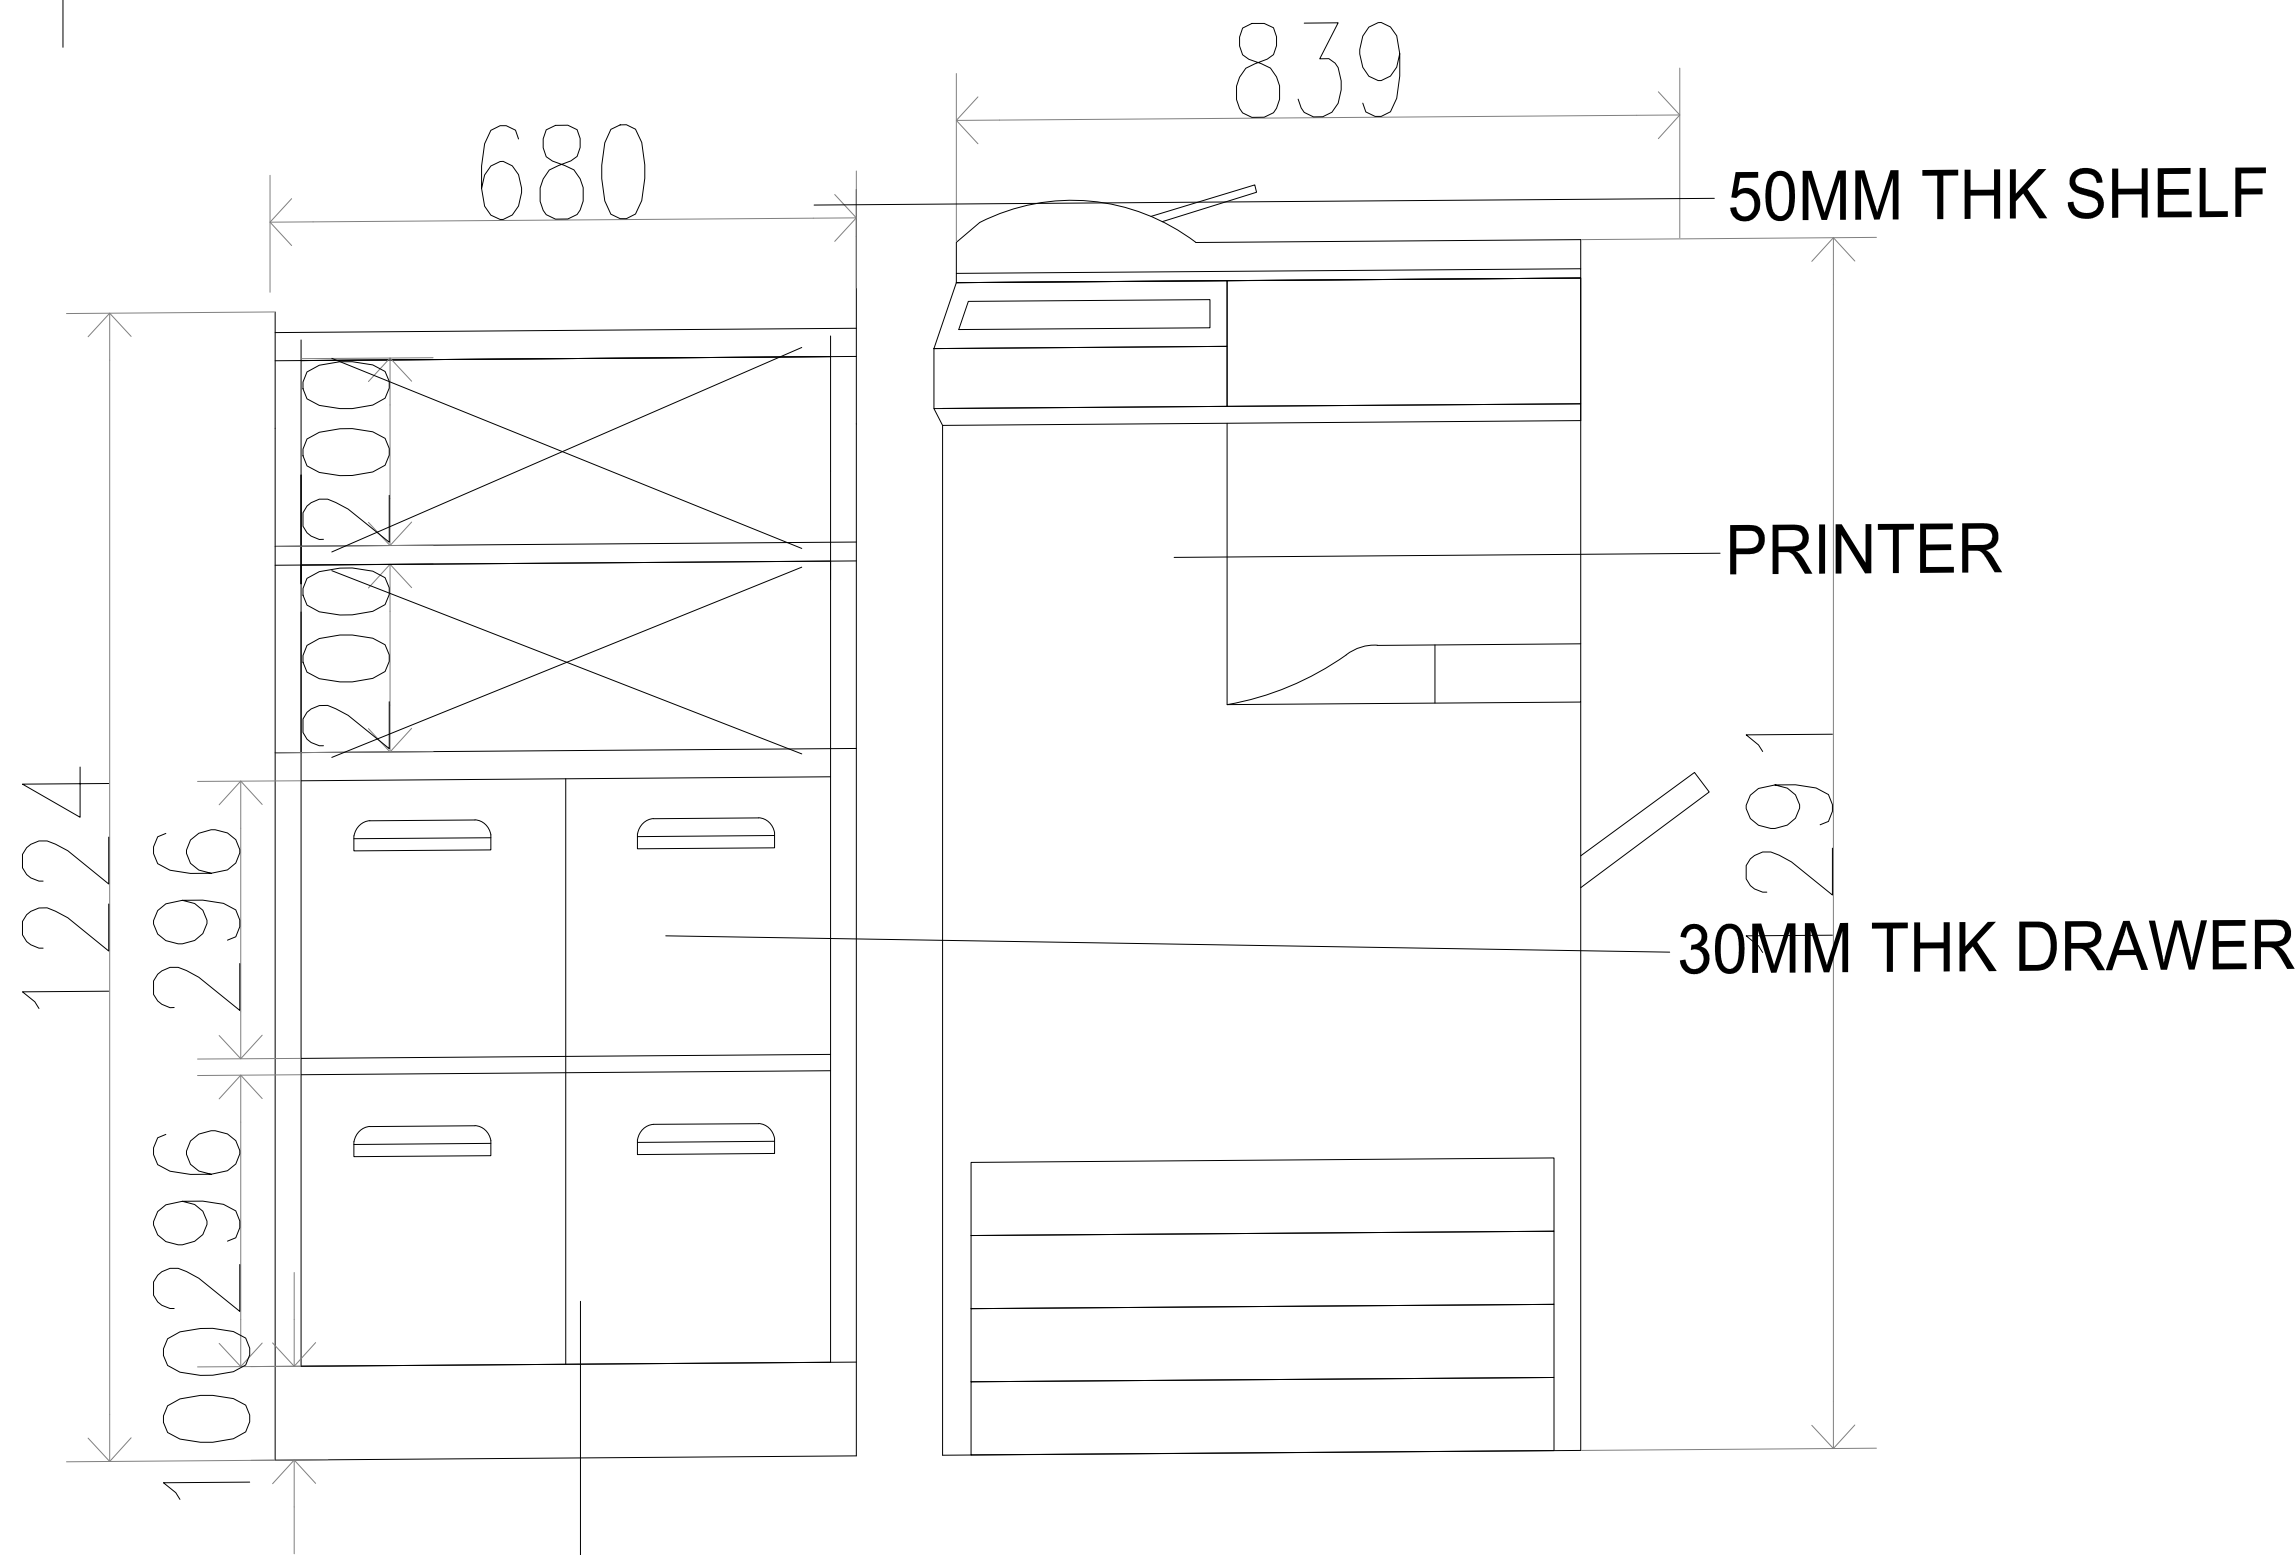

MAICA LAMINATE DIAMOND
COLLECTION M32400
LUMINOUS ASH

Front View

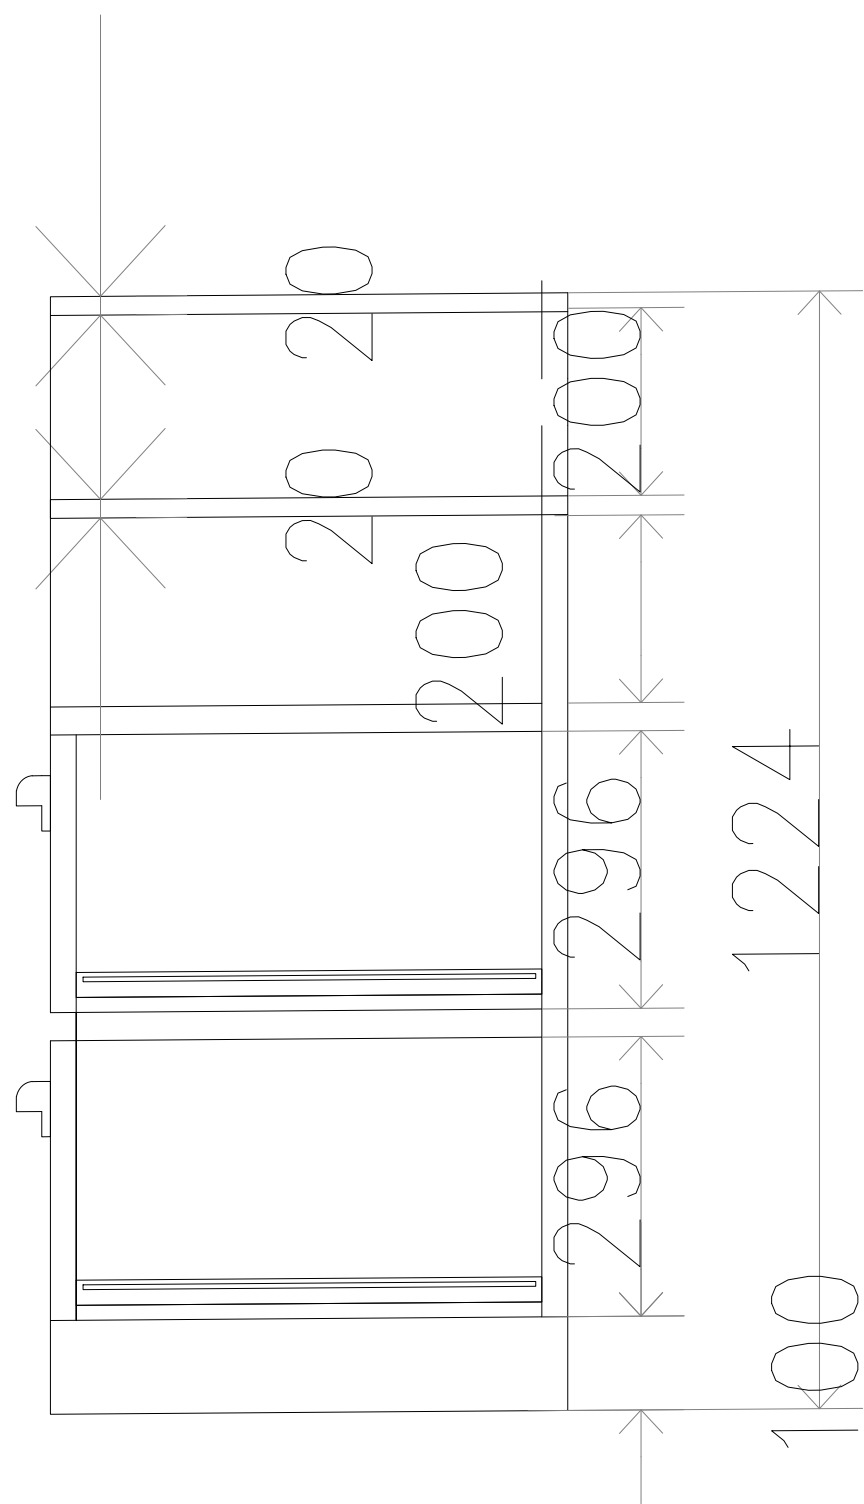

Side View

P5

Client / Developer :



PUTRAJAYA HOLDINGS
PUTRAJAYA HOLDINGS SDN. BHD (co.No.364152-K)
BLOK 1, MENARA SERI WILAYAH, PRECINCT 2
62100 PUTRAJAYA
TEL : 03-8883 8888 FAX : 03-8889 5499

Design & Built Contractor :




SPACE SCAPE

CONTRACTORS' IN-HOUSE CONSULTANT :

Architect :

Civil & Structure Engineer :

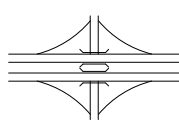

PERUNDING AZIZ, AZALI & TEE SDN. BHD.
NO. 9, JALAN KEMER 2,
BANGAR PUCHONG JAYA,
47100 PUCHONG,
SELANGOR
TEL : 03-5882 7485/7385
FAX : 03-5882 4674

Mechanical & Electrical Engineer :



PERUNDING UNIREKA
NO. 17-17-18,
JALAN KEMARI 5,
47100 PUCHONG,
SELANGOR, DARUL EHSAN
TEL : 03-80761028
FAX : 03-80761029
E-mail : unireka@gmail.com

Landscape Architect :



VERITAS LANDSCAPE SDN BHD
8-15, BLOK B, MEDAN AVENUE 2,
12, JALAN TAP KIRAN SENG,
50450 WILAYAH PERSEKUTUAN KUALA LUMPUR
TEL : +603 21636971 FAX : +603 21636970

Facade Consultant :



Aurecon Singapore (Pte.) Ltd.
No. 157, BEACH ROAD,
#22-02, GATEWAY EAST,
SINGAPORE 189721
TEL : +65 6256 8188
FAX : +65 6251 7188
E-mail : singapore@ap.aurecongroup.com

Quantity Surveyor :



KPK QUANTITY SURVEYORS (SEMANAUNG) SDN BHD
18-6 & 18-7, BLOK B, 18TH FLOOR MEDAN,
AVENUE 1, 12 JALAN TAP KIRAN SENG,
50450 WILAYAH PERSEKUTUAN KUALA LUMPUR
TEL : +603 21668000 FAX : +603 21668225

Green Building Consultant :



Exergy Malaysia Sdn Bhd
198 & 218, JALAN 17 / 45, 46400 PETALING JAYA,
SELANGOR DARUL EHSAN
TEL : +603 79583655 FAX : +603 79563660

Project Title :

**CADANGAN UBAHSUAI
TEMPAT KERJA JABAT
MENARA PJH TINGKAT 10
PEMBANGUNAN 3 BLOK**

**UNTUK:
UNITED NATIONS MALAYSIA**

Drawing Title :

FURNITURE P5 DETAIL

Electrical Contractor :



OMEGA ELECTRICAL
D'ALANNA SHEPLOT
UNIT NO. 2-01-50,
JALAN PLOU ULU CHERAS,
56100 KUALA LUMPUR.

Signature of Client / Developer :

Signature of M&E :

Contract No. :

--	--	--	--	--	--


No. Lukisan :

Drawings No. :


--	--	--	--

Amendments


Revision No.	Date	Notes	Status

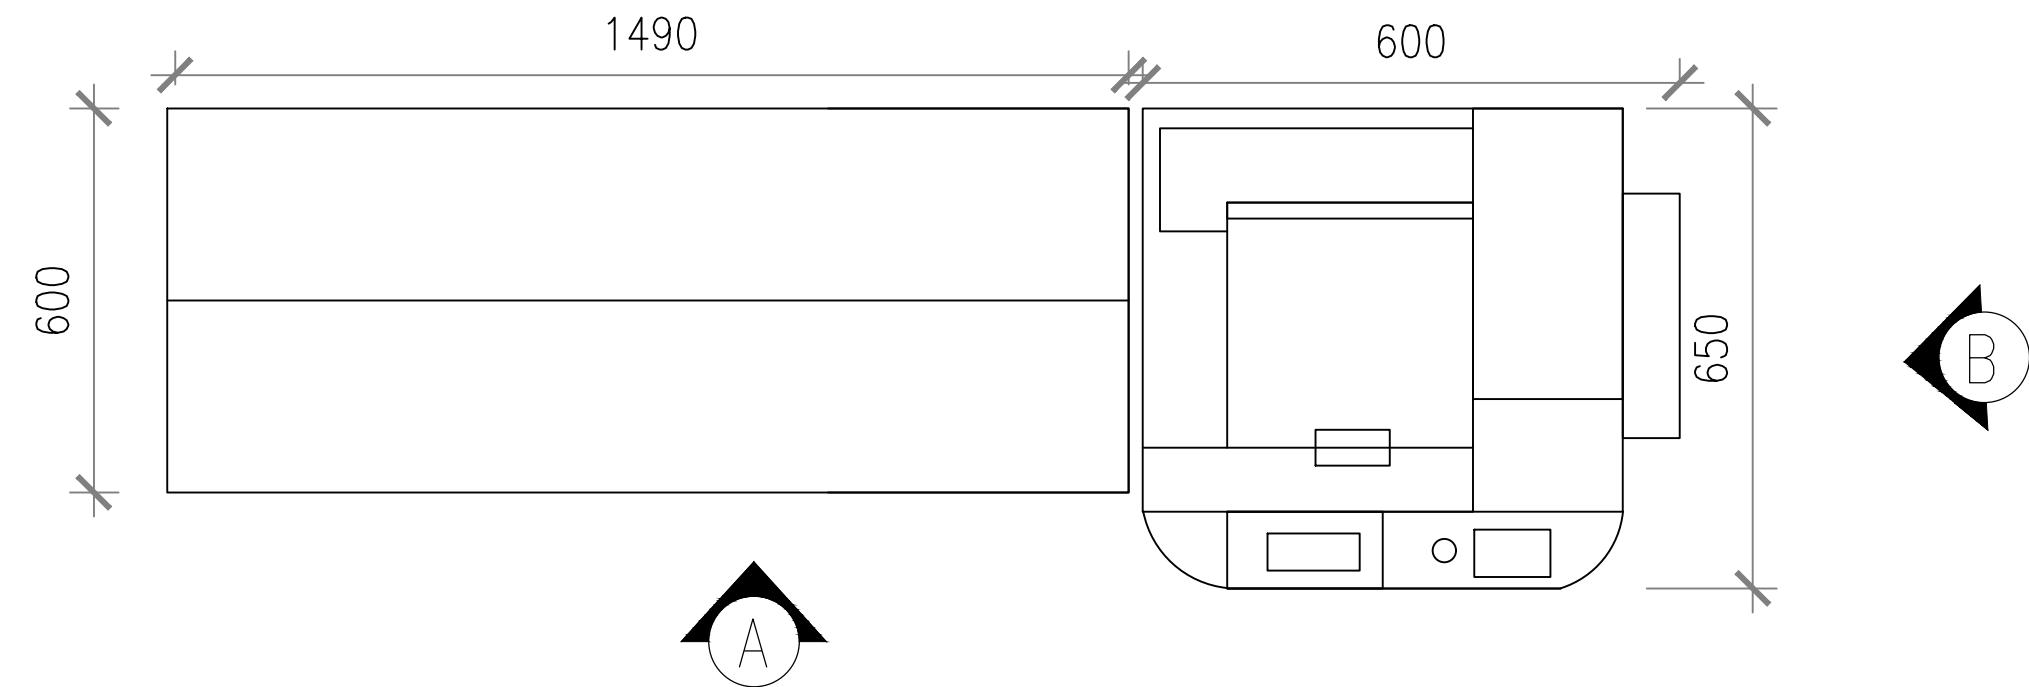

PRINTING STATION 7 TOP VIEW
SCALE : 1:30

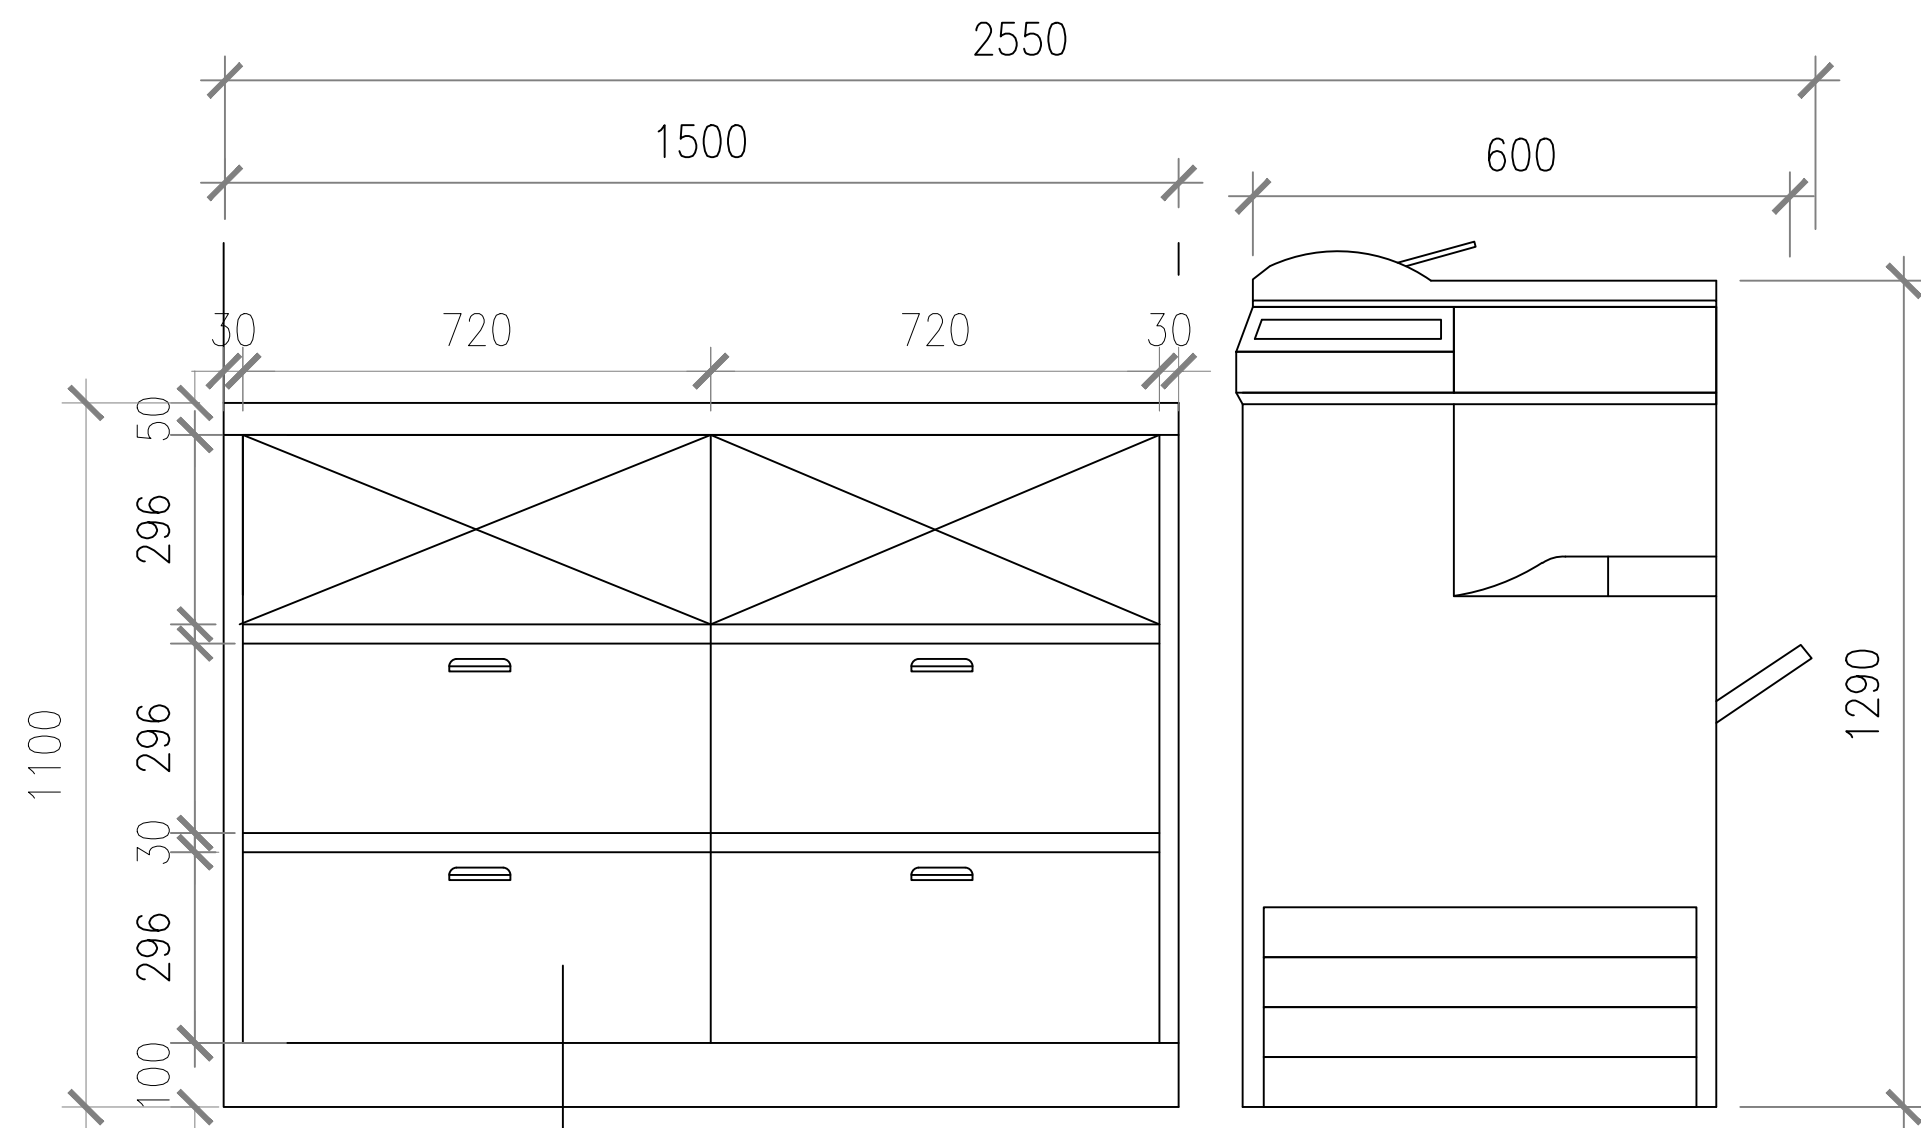

PRINTING STATION 7 ELEVATION A
SCALE : 1:30

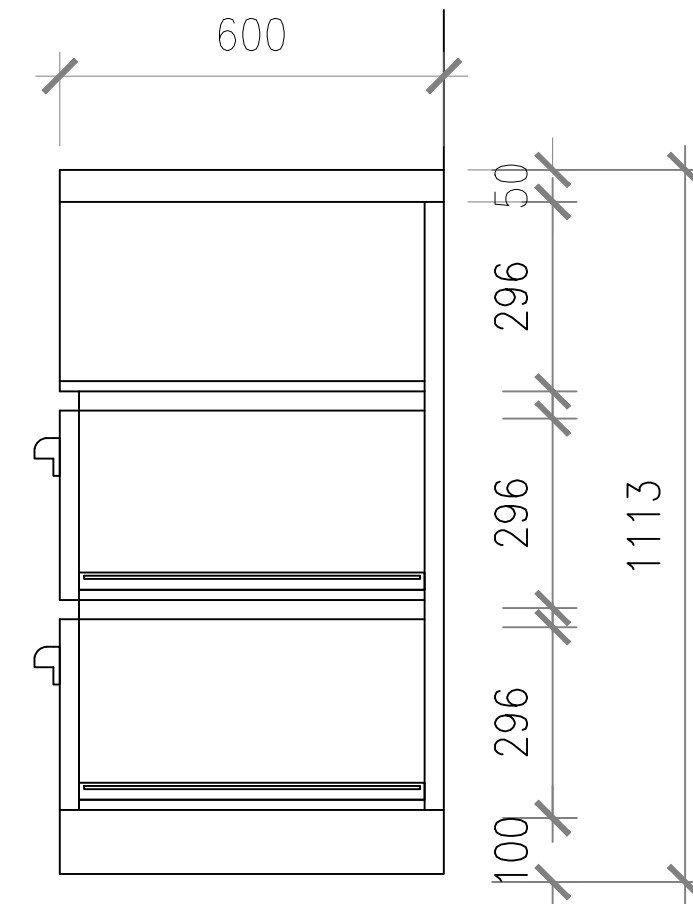

PRINTING STATION 7 ELEVATION B
SCALE : 1:30

Client / Developer :



PUTRAJAYA HOLDINGS
PUTRAJAYA HOLDINGS SDN. BHD (co.No.364152-K)
BLOK 1, MENARA SERI WILAYAH, PRECINCT 2
62100 PUTRAJAYA
TEL : 03-8883 8888 FAX : 03-8889 5499

Design & Built Contractor :




CONTRACTORS IN-HOUSE CONSULTANT :

Architect :



JAFRI MERICAN ARCHITECT
1-3, JALAN DUNGU 28 4/1,
TAMAN SUNGAI BESI INDAH,
43000 SUNGAI BESI INDAH,
SELANGOR
TEL: 03-89419481 FAX : 03-89419482
E-mail : jafri@jmericanarchitect.com.my

Civil & Structure Engineer :

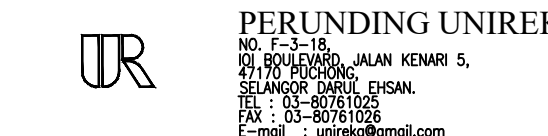

PERUNDING AZIZ, AZALI & TEE SDN. BHD.
NO. 9, JALAN KEMAR 2,
BANGSA PUCHONG JAYA,
47100 PUCHONG,
SELANGOR
TEL: 03-5682 7485/7385
FAX: 03-5682 4674

Mechanical & Electrical Engineer :




PERUNDING UNIREKA
NO. 15-16,
71, ROH BUKIT,
JALAN KEMAR 5,
BANGSA PUCHONG JAYA,
47100 PUCHONG,
SELANGOR
TEL: 03-56761768
FAX: 03-56761769
E-mail : unireka@gmail.com

Landscape Architect :



VERITAS LANDSCAPE SDN BHD
8-12-15, BLOCK B, MEWA AVENUE 2,
12, JALAN YAP KIAN SENG,
50450 WILAYAH PERSEKUTUAN KUALA LUMPUR
TEL: +603 21636971 FAX: +603 21636970

Facade Consultant :

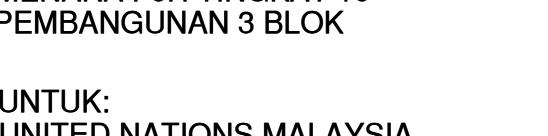


Aurecon Singapore (Pte.) Ltd.
No. 152-BEACH ROAD,
#22-02 GATEWAY EAST,
SINGAPORE 109772
TEL : +65 6256 6188
FAX : +65 6251 7188
E-mail : singapore@ap.aurecongroup.com

Quantity Surveyor :



KPK QUANTITY SURVEYORS (SEMENTANJUNG) SDN BHD
18-6 & 18-7, BLOCK B, 18TH FLOOR MEGAN,
AVENUE 1, 12, JALAN YAP KIAN SENG,
50450 WILAYAH PERSEKUTUAN KUALA LUMPUR
TEL: +603 21668000 FAX: +603 21668228

Green Building Consultant :

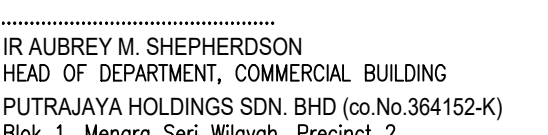

Exergy Malaysia Sdn Bhd
198 & 218, JALAN 17 / 45, 46400 PETALING JAYA,
SELANGOR DARUL EHSAN
TEL: +603 79583655 FAX: +603 79583660

Project Title :


CADANGAN UBAHSUAI
TEMPAT KERJA JABAT
MENARA PJH TINGKAT 10
PEMBANGUNAN 3 BLOK

UNTUK:
UNITED NATIONS MALAYSIA

Drawing Title :

PRINTING STATION P7 DETAILS

Electrical Contractor :

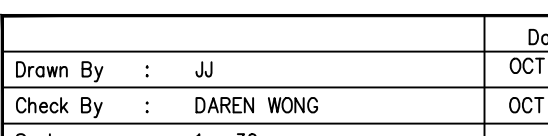

OMEGA ELECTRICAL
D'ALAMANDA SHOPLOT
UNIT NO. 2-011-201-202
JALAN PUEU ULU CHEONG,
56100 KUALA LUMPUR

Signature of Client / Developer :


IR AUBREY M. SHEPHERDSON
HEAD OF DEPARTMENT, COMMERCIAL BUILDING
PUTRAJAYA HOLDINGS SDN. BHD (co.No.364152-K)
Blok 1, Menara Seri Wilayah, Precinct 2
62100 Putrajaya
Tel : 03-8883 8888 Fax : 03-8889 5499

Signature of M&E :

Contract No. :
No. Lukisan :
Drawn By : JJ Date: OCT 2017
Check By : DAREN WONG Date: OCT 2017
Scale : 1 : 30

Drawings No. :

Amendments
Revision No. Date Notes Status:

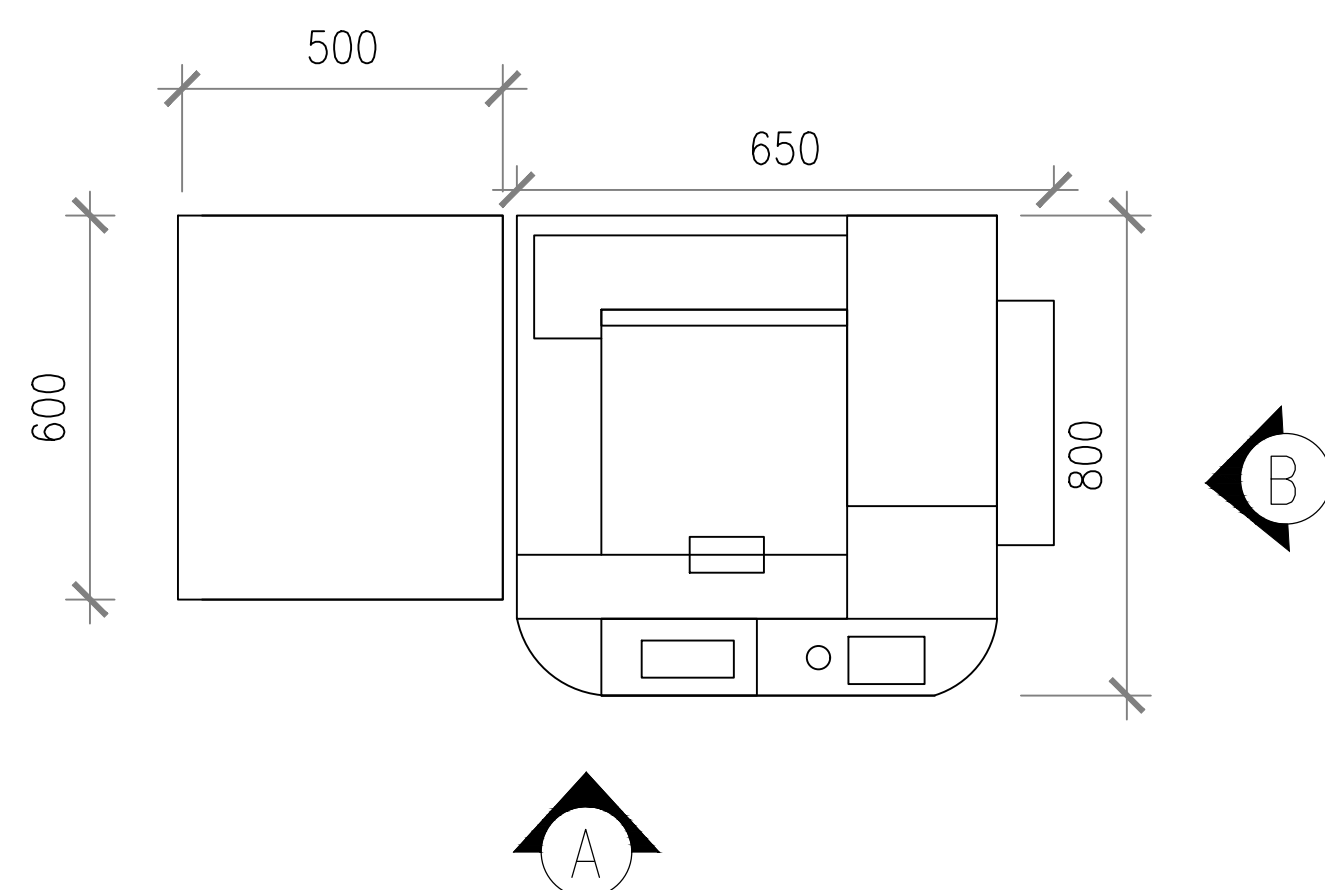

Technical drawing of the MAICA LAMINATE DIAMOND COLLECTION M32400 LUMINOUS ASH, showing front and side views with dimensions.

Dimensions:


- Overall width: 1500
- Individual unit width: 650
- Overall height: 1290
- Front view height segments (from top to bottom): 50, 296, 30, 296, 30, 296, 100
- Total front view height: 1100

**MAICA LAMINATE DIAMOND
COLLECTION M32400
LUMINOUS ASH**


Technical drawing of a three-part cabinet (Kombi-Schrank) showing the front elevation. The drawing includes dimensions for the overall height and the individual sections. The total height is 1100 mm. The sections are divided into three main parts, each 296 mm high, with a top section of 50 mm and a bottom section of 100 mm. The drawing also shows the internal structure and the placement of the doors.

Client / Developer :			
 PUTRAJAYA HOLDINGS PUTRAJAYA HOLDINGS SDN BHD (co.No.364152-K) Blok 1, Menara Seri Wilayah, Precinct 2 62100 PUTRAJAYA. TEL : 03-8883 8888 FAX : 03-8889 5499			
Design & Built Contractor :			
			
CONTRACTOR'S IN-HOUSE CONSULTANT:			
Architect :		 JAFFRI MERICAN ARCHITECT 1-3, JALAN DAGANG SB 4/1, TAMAN SURGA BESI INDAH, 43300 SERI KEMBANGAN, SELANGOR DARUL EHSAN. TEL: 03-89419481 FAX : 03-89419482 E-mail : jaffri@jaffrimericanarchitect.com.my	
Civil & Structure Engineer :		 PERUNDING AZIZ, AZALI & TEE SDN. BH. NO. 9, JALAN KENARI 2, BANDAR PUCHONG JAYA, 47100 PUCHONG, SELANGOR TEL: 03-5882 7485/7385 FAX: 03-5882 4674	
Mechanical & Electrical Engineer :		 PERUNDING UNIREKA NO. 5-3, KJ, BONDAYU, JALAN KEMAS 5, SELANGOR DARTUL EHSAN, 47100 PUCHONG, SELANGOR TEL: 03-80761028 FAX: 03-80761028 e-mail : unireka@gmail.com	
Landscape Architect :		 VERITAS LANDSCAPE SDN BHD 8-12-15, BLOCK B, MEGAN AVENUE 2, 12, JALAN YAP KWAN SENG, 50450 WILAHY PERSEKUTUAN KUALA LUMPUR TEL: 03-21636971 FAX: +603 21636970	
Facade Consultant :		Aurecon Singapore (Pte.) Ltd  822-102 CENTRAL EAST, #05-01, 100 ROBINSON ROAD, SINGAPORE 068971 TEL : +65 6256 6188 FAX : +65 6251 7188 E-mail : singapore@ap.aureconsgroup.com	
Quantity Surveyor :		 KPK QUANTITY SURVEYORS (SIEMENSIAN) SDN BHD 18-B & 18-7, BLOCK B, 18TH FLOOR MEKAN, MENARA PJH, 12 JALAN YAP KWAN SENG, 50450 WILAHY PERSEKUTUAN KUALA LUMPUR TEL: +603 21688000 FAX: +603 21688228	
Green Building Consultant :		 Exergy Malaysia Sdn Bhd 19B & 21B, JALAN 17 / 45, 46400 PETALING JAYA, SELANGOR DARUL EHSAN. TEL: 03-79563655 FAX: +603 79563660	
Project Title :			
CADANGAN UBAHSUAI TEMPAT KERJA JABAT MENARA PJH TINGKAT 10 PEMBANGUNAN 3 BLOK			
UNTUK: UNITED NATIONS MALAYSIA			
Drawing Title :			
PRINTING STATION PB DETAILS			
Electrical Contractor :		 OMEGA ELECTRICAL d'ALAMANDA SHOPLOT UNIT NO. 2-01-01, JALAN PUJUI LOU IMPIAN 4, JALAN KUDA ULU CHENG, 56100 KUALA LUMPUR.	
Signature of Client / Developer :			
..... IR AUBREY M. SHEPHERDSON HEAD OF DEPARTMENT, COMMERCIAL BUILDING PUTRAJAYA HOLDINGS SDN. BHD (co.No.364152-K) Blok 1, Menara Seri Wilayah, Precinct 2 62100 Putrajaya Tel : 03-8883 8888 Fax : 03-8889 5499			
Signature of M&E :			
..... _____			
Contract No. :			
No. Lukisan :			
Drawn By :		Date	
JJ		OCT 2017	
Check By :		OCT 2017	
DAREN WONG			
Scale :			
1 : 30			
Drawings No. :			
Amendments			
Revision No.	Date	Notes	Status:

P9

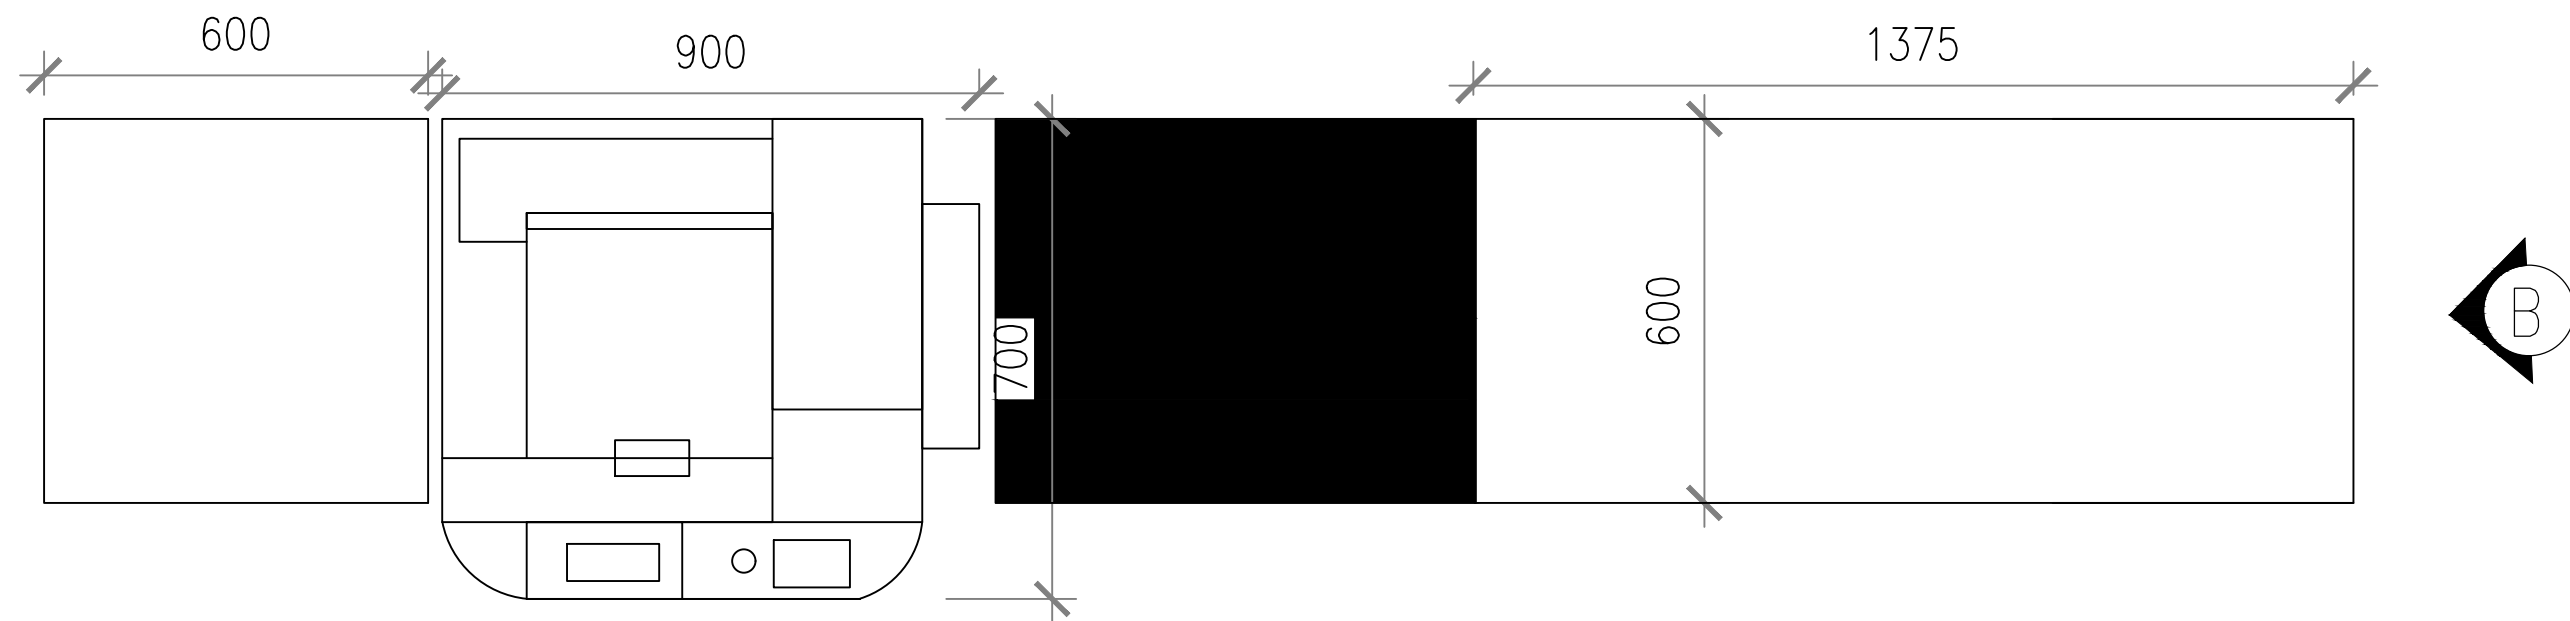


PRINTING STATION 9 TOP VIEW
SCALE : 1:30

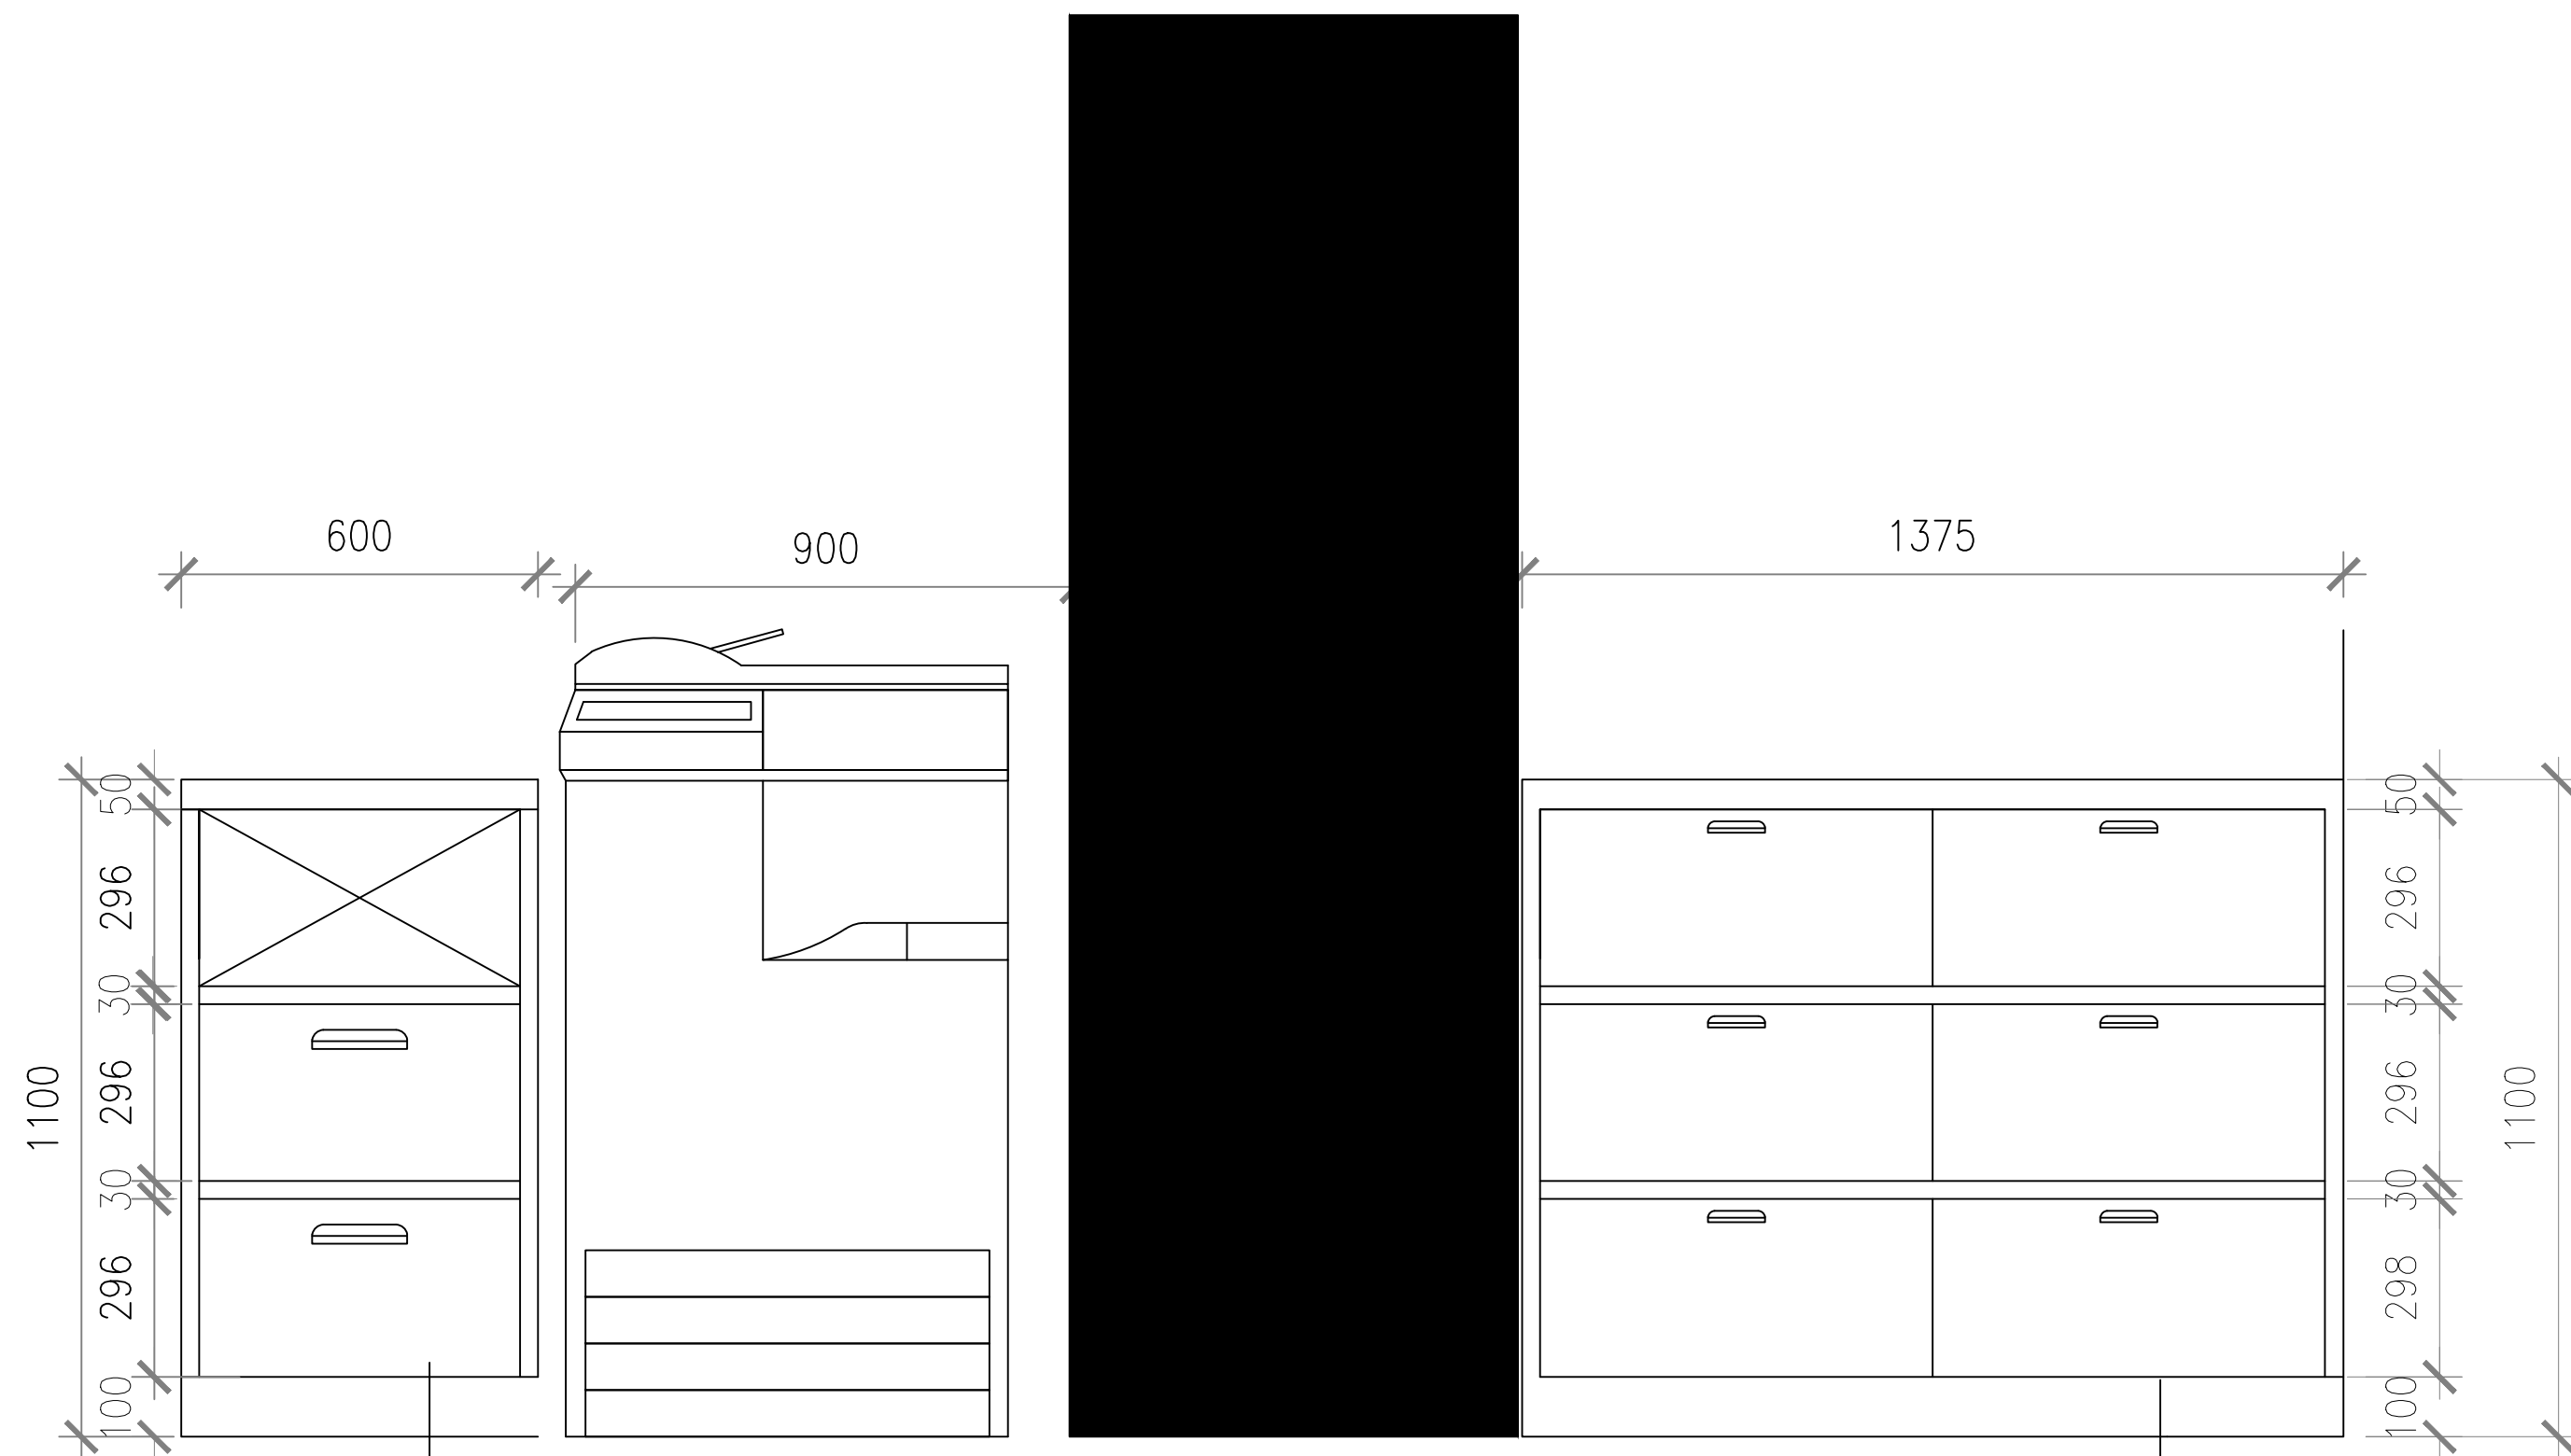

MAICA LAMINATE DIAMOND
COLLECTION M32400
LUMINOUS ASH

PRINTING STATION 9 ELEVATION A
SCALE : 1:30

MAICA LAMINATE DIAMOND
COLLECTION M32400
LUMINOUS ASH

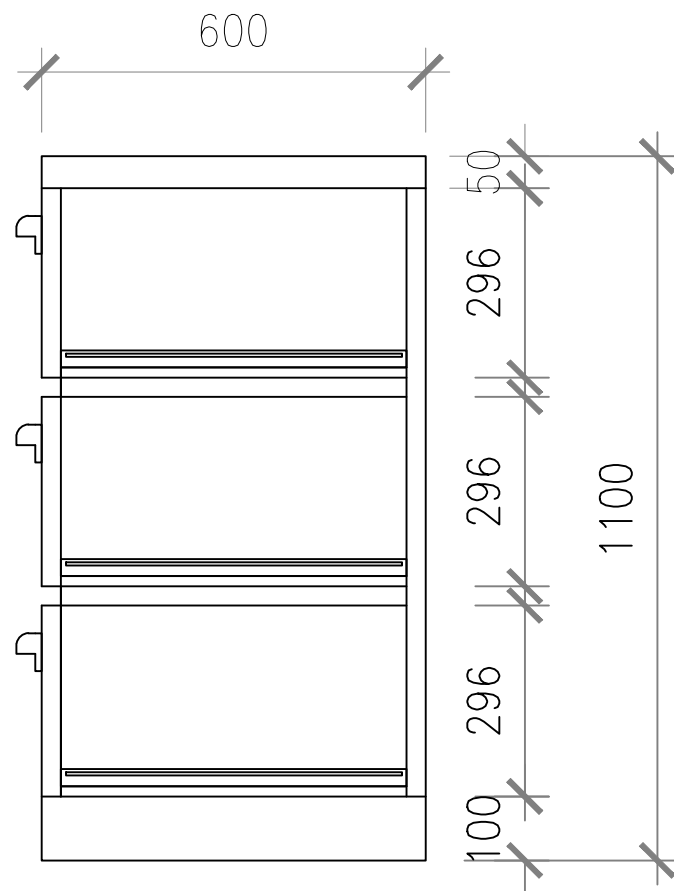

PRINTING STATION 9 ELEVATION B
SCALE : 1:30

Client / Developer :

PUTRAJAYA HOLDINGS
PUTRAJAYA HOLDINGS SDN. BHD (co.No.364152-K)
BLOK 1, MENARA SERI WILAYAH, PRECINCT 2
62100 PUTRAJAYA
TEL : 03-8883 8888 FAX : 03-8889 5499

Design & Built Contractor :

SPACE SPACE

CONTRACTORS IN-HOUSE CONSULTANT :

Architect :

JAFRI MERICAN ARCHITECT
11-12, JALAN BERING 28/41,
TAMAN SUNGAI BESI INDAH,
43000 SUNGAI BESI INDAH,
SELANGOR
TEL: 03-89419481 FAX : 03-89419482
E-mail : jafri@jmericanarchitect.com.my

Civil & Structure Engineer :

PERUNDING AZIZ, AZALI & TEE SDN. BHD.
NO. 9, JALAN KEMAR 2,
BANGSA PUCHONG JAYA,
47100 PUCHONG,
SELANGOR
TEL: 03-5882 7485/7385
FAX: 03-5882 4674

Mechanical & Electrical Engineer :

PERUNDING UNIREKA
NO. 15-16,
JALAN KEMAR 5,
BANGSA PUCHONG JAYA,
47100 PUCHONG,
SELANGOR
TEL: 03-89761788
FAX: 03-89761789
E-mail : unireka@gmail.com

Landscape Architect :

VERITAS LANDSCAPE SDN BHD
8-12-15, BLOCK B, MEWA AVENUE 2,
12, JALAN YAP KIAN SENG,
50450 WILAYAH PERSEKUTUAN KUALA LUMPUR
TEL: +603 21636971 FAX: +603 21636970

Facade Consultant :

Aurecon Singapore (Pte.) Ltd.
No. 152-BEACH ROAD,
#22-02 GATEWAY EAST,
SINGAPORE 189772
TEL : +65 6256 6188
FAX : +65 6251 7188
E-mail : singapore@ap.aurecongroup.com

Quantity Surveyor :

KPK QUANTITY SURVEYORS (SEMEANJUNG) SDN BHD
18-6 & 18-7, BLOCK B, 18TH FLOOR MEGAN,
AVENUE 8, 12, JALAN YAP KIAN SENG,
50450 WILAYAH PERSEKUTUAN KUALA LUMPUR
TEL: +603 21668000 FAX: +603 21668228

Green Building Consultant :

Exergy Malaysia Sdn Bhd
198 & 218, JALAN 17 / 45, 46400 PETALING JAYA,
SELANGOR DARUL EHSAN
TEL: +603 79583655 FAX: +603 79583660

Project Title :

**CADANGAN UBAHSUAI
TEMPAT KERJA JABAT
MENARA PJH TINGKAT 10
PEMBANGUNAN 3 BLOK
UNTUK:
UNITED NATIONS MALAYSIA**

Drawing Title :

PRINTING STATION P9 DETAILS

Electrical Contractor :

OMEGA ELECTRICAL
D'ALAMANDA SHOPLOT
UNIT NO. 2-01-01-01-02-03-04
JALAN PUEU ULU CHEWAS,
56100 KUALA LUMPUR

Signature of Client / Developer :

.....
IR AUBREY M. SHEPHERDSON
HEAD OF DEPARTMENT, COMMERCIAL BUILDING
PUTRAJAYA HOLDINGS SDN. BHD (co.No.364152-K)
Blok 1, Menara Seri Wilayah, Precinct 2
62100 Putrajaya
Tel : 03-8883 8888 Fax : 03-8889 5499

Signature of M&E :

.....

Contract No. :

.....

No. Lukisan :



Drawn By	: JJ	Date	: OCT 2017
Check By	: DAREN WONG	Date	: OCT 2017
Scale	: 1 : 30		

Drawings No. :


.....

Amendments


Revision No.	Date	Notes	Status:

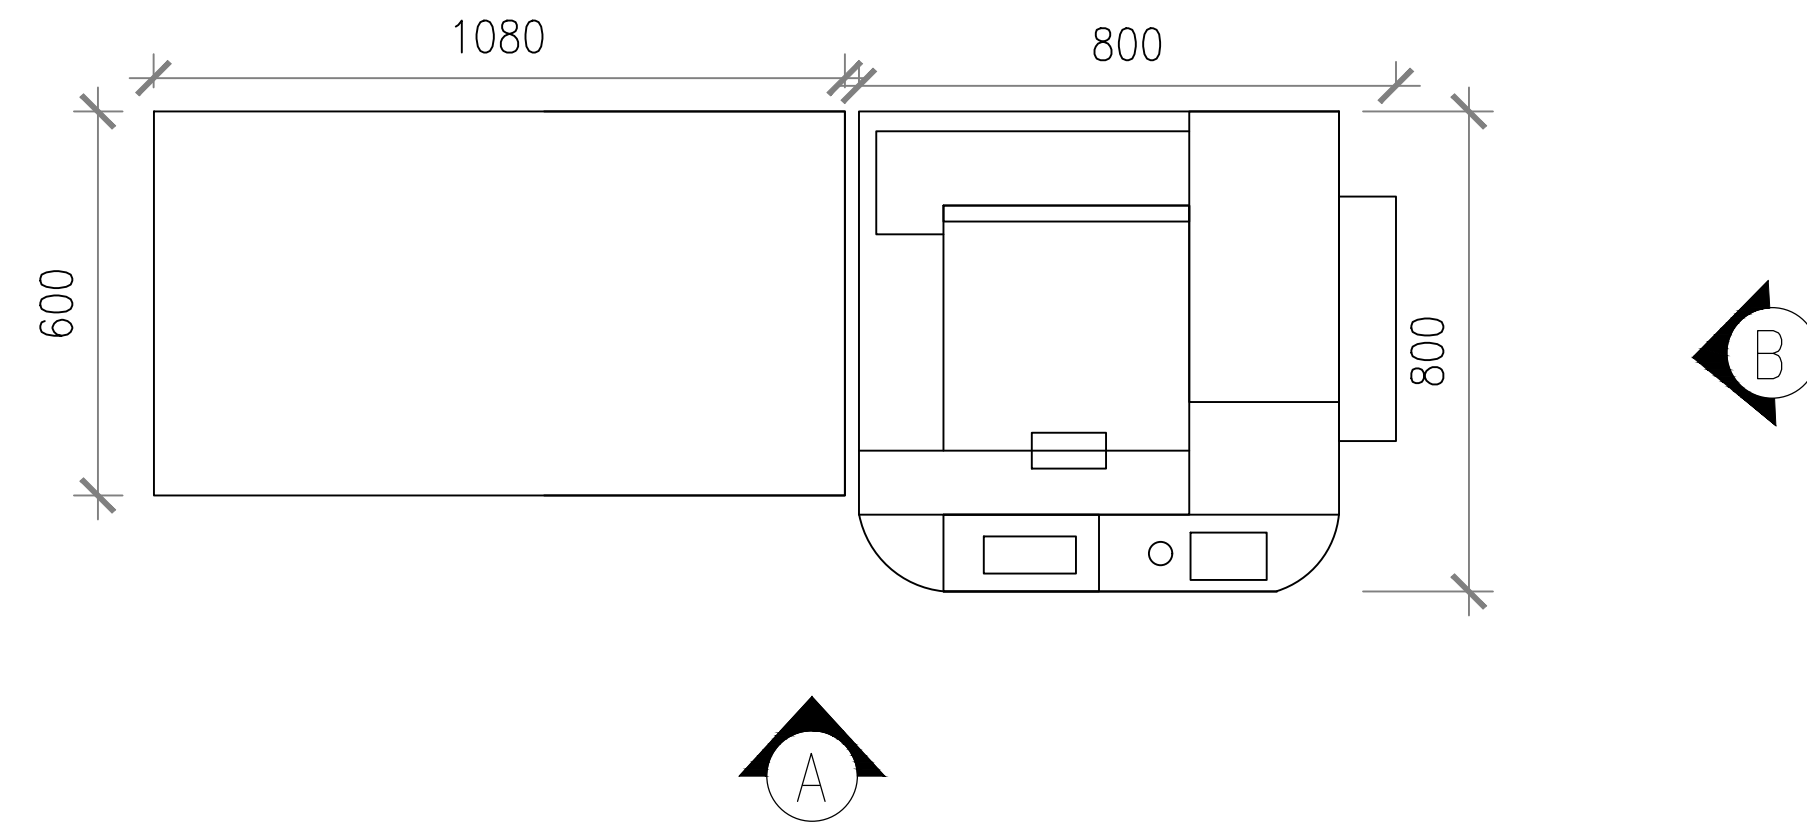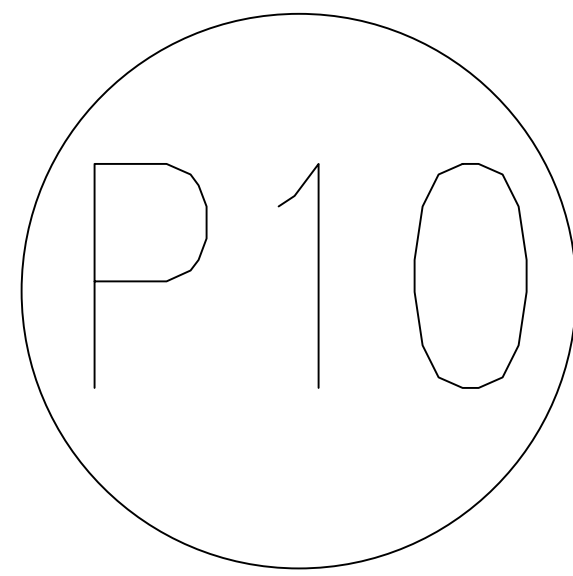

PRINTING STATION 10 TOP VIEW
SCALE : 1:30

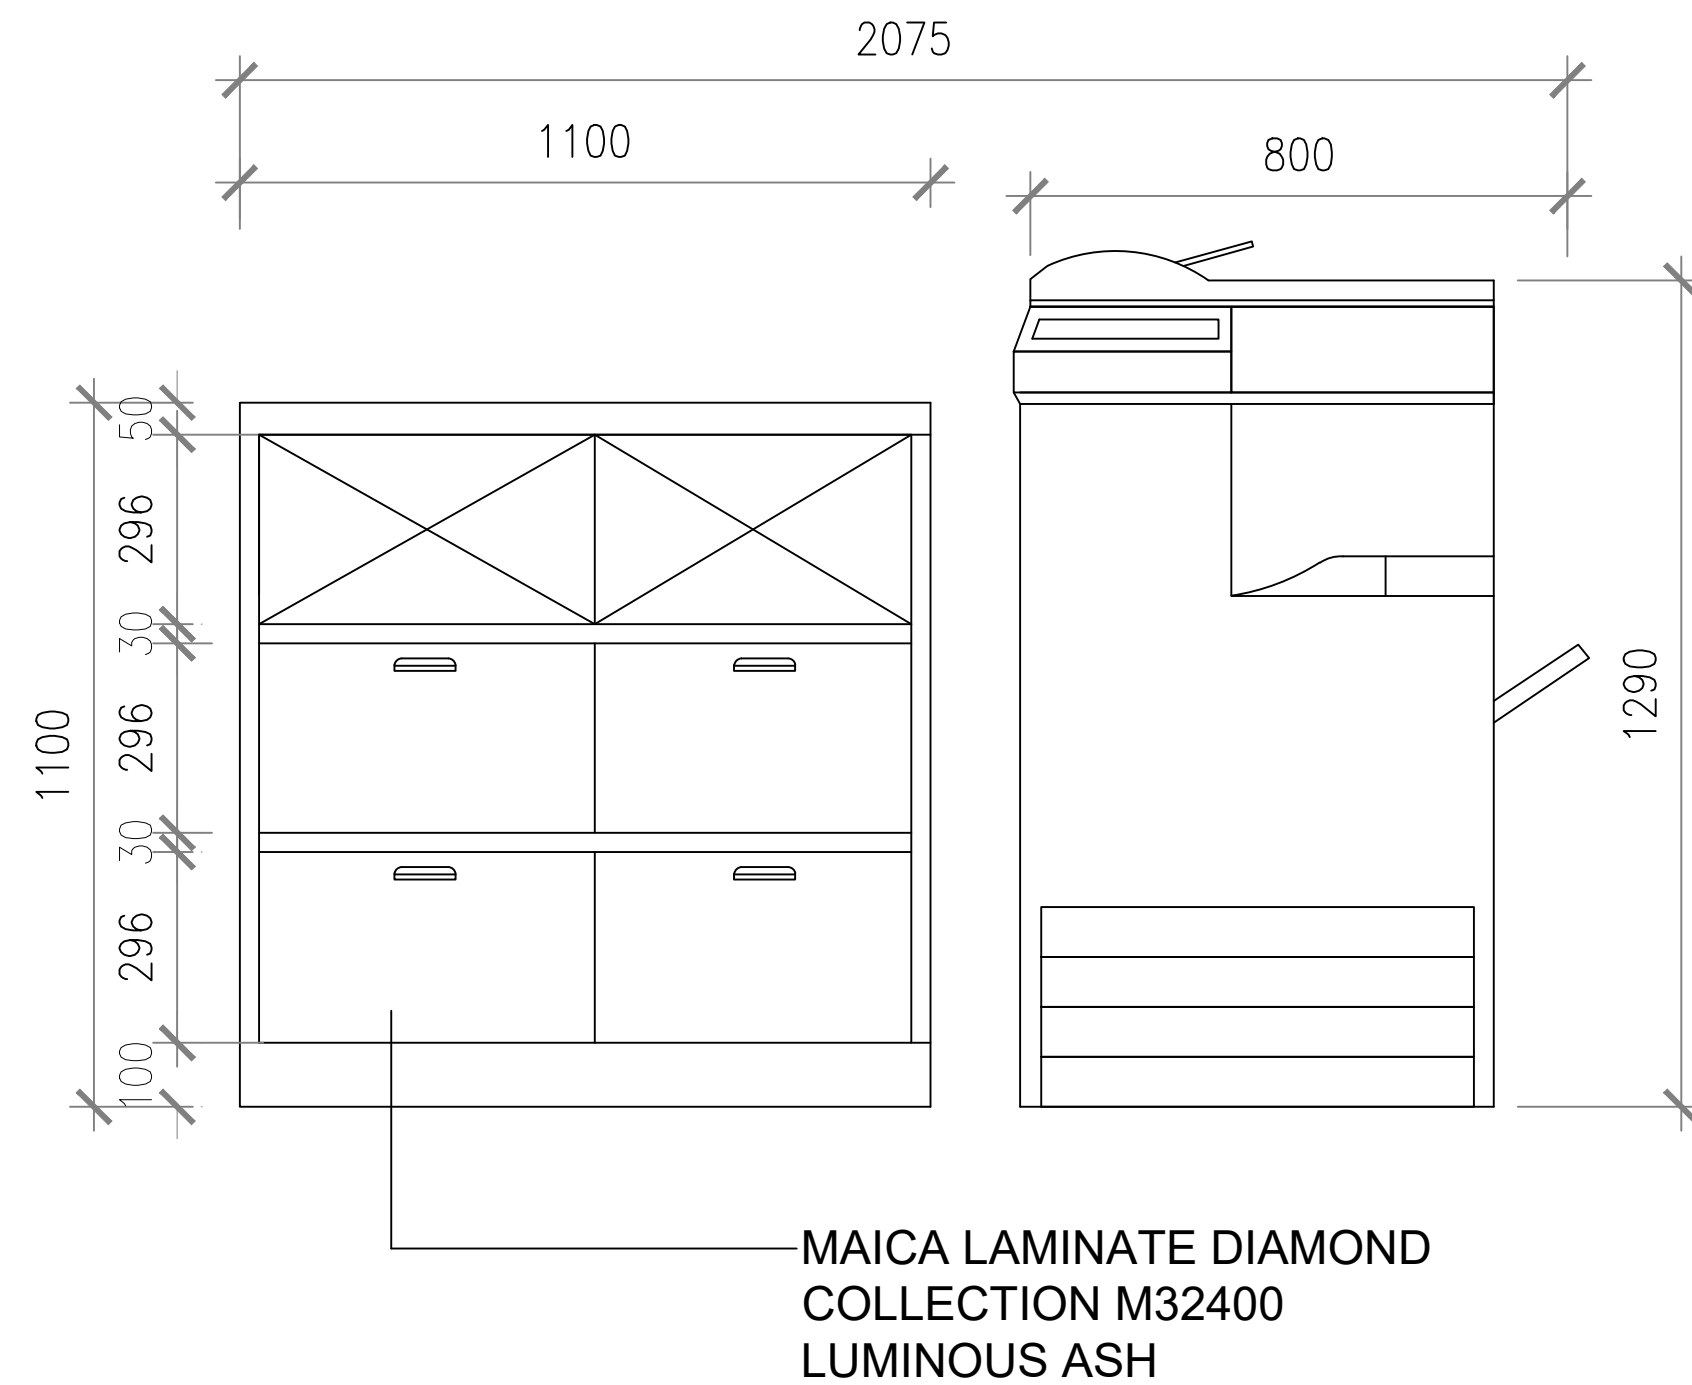

PRINTING STATION 10 ELEVATION A
SCALE : 1:30

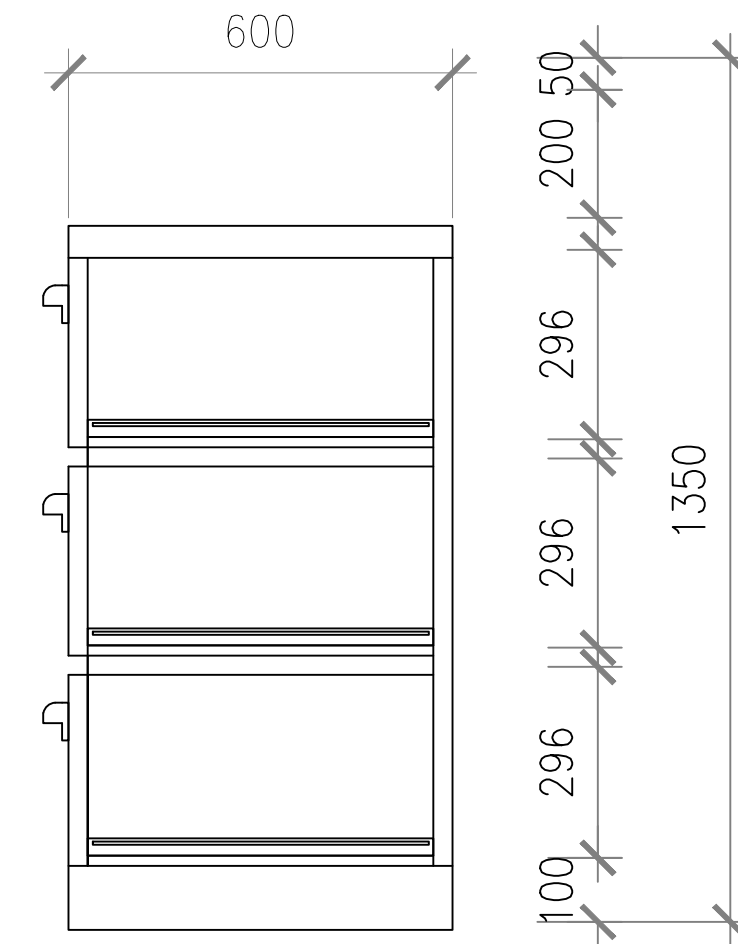

PRINTING STATION 10 ELEVATION B
SCALE : 1:30

Client / Developer :



PUTRAJAYA HOLDINGS
PUTRAJAYA HOLDINGS SDN. BHD (co.No.364152-K)
BLOK 1, MENARA SERI WILAYAH, PRECINCT 2
62100 PUTRAJAYA
TEL : 03-8883 8888 FAX : 03-8889 5499

Design & Built Contractor :



CONTRACTORS IN-HOUSE CONSULTANT :

Architect :



Civil & Structure Engineer :
PERUNDING AZIZ, AZALI & TEE SDN. BHD.
NO. 9, JALAN KEMAR 2,
BANGSA PUCHONG JAYA,
47100 PUCHONG,
SELANGOR
TEL: 03-5882 7485/7385
FAX: 03-5882 4674

Mechanical & Electrical Engineer :

 


Landscape Architect :
VERITAS LANDSCAPE SDN BHD
8-12-15, BLOCK B, MEWA AVENUE 2,
12, JALAN YAP KIAN SENG,
50450 WILAYAH PERSEKUTUAN KUALA LUMPUR
TEL: +603 21636971 FAX: +603 21636970

Facade Consultant :

Aurecon Singapore (Pte.) Ltd.
No. 152-BEACH ROAD,
#22-02 GATEWAY EAST,
SINGAPORE 189771
TEL : +65 6256 6188
FAX : +65 6251 7188
E-mail : singapore@ap.aurecongroup.com

Quantity Surveyor :



Green Building Consultant :
Exergy Malaysia Sdn Bhd
198 & 218, JALAN 17 / 45, 46400 PETALING JAYA,
SELANGOR DARUL EHSAN
TEL: +603 79583655 FAX: +603 79583660

Project Title :


CADANGAN UBAHSUAI
TEMPAT KERJA JABAT
MENARA PJH TINGKAT 10
PEMBANGUNAN 3 BLOK

UNTUK:
UNITED NATIONS MALAYSIA

Drawing Title :

PRINTING STATION P10 DETAILS

Electrical Contractor :

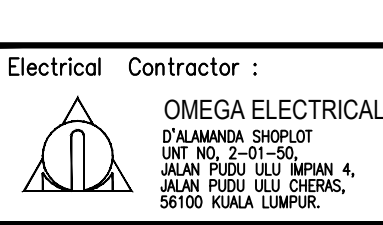

Signature of Client / Developer :

Signature of M&E :

IR AUBREY M. SHEPHERDSON
HEAD OF DEPARTMENT, COMMERCIAL BUILDING
PUTRAJAYA HOLDINGS SDN. BHD (co.No.364152-K)
Blok 1, Menara Seri Wilayah, Precinct 2
62100 Putrajaya
Tel : 03-8883 8888 Fax : 03-8889 5499

Contract No. :


No. Lukisan :

Drawn By : JJ Date: OCT 2017
Check By : DAREN WONG OCT 2017
Scale : 1 : 30


Drawings No. :

Amendments

Revision No.	Date	Notes	Status

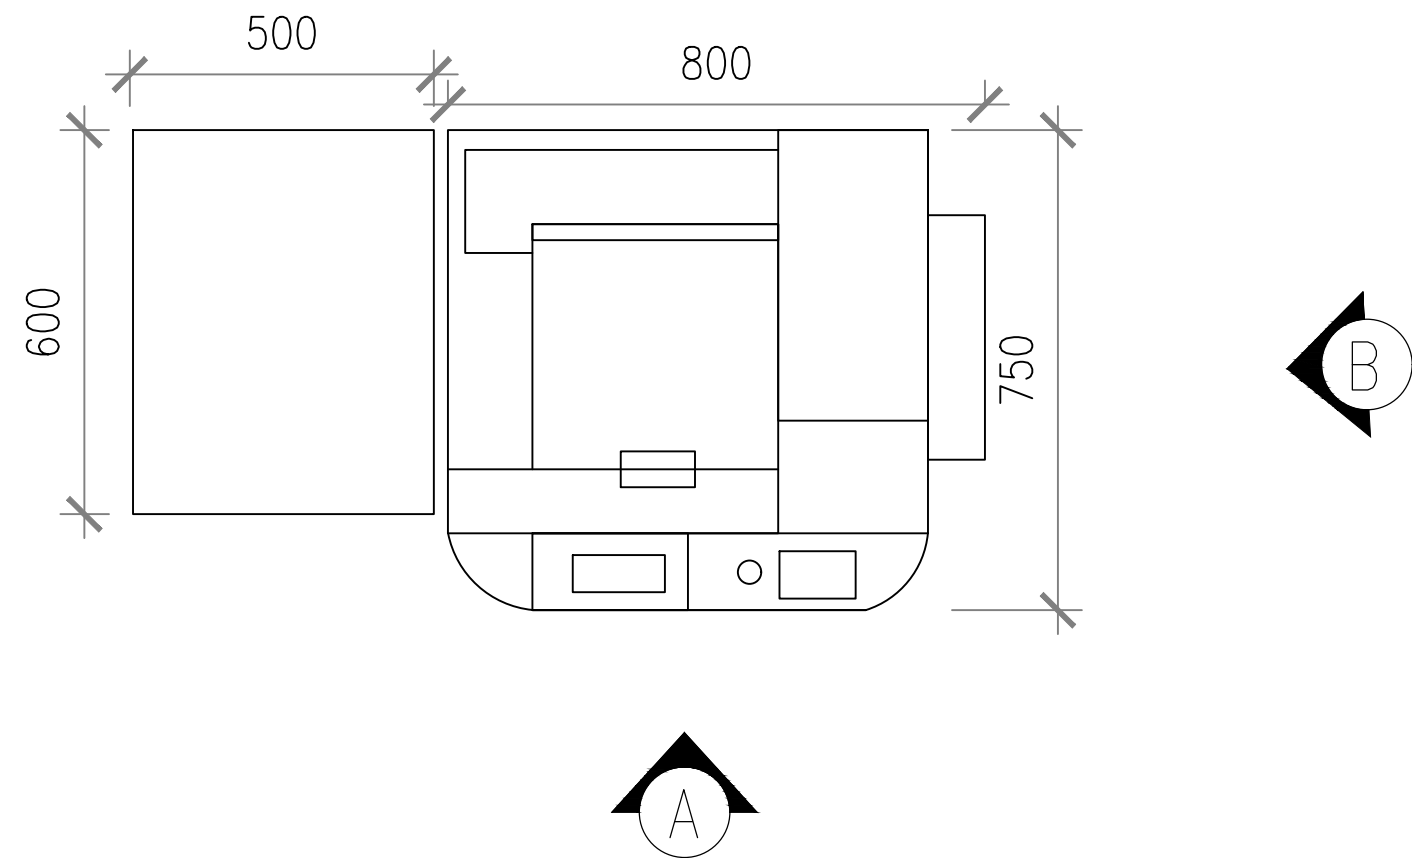


PRINTING STATION 11 TOP VIEW
SCALE : 1:30

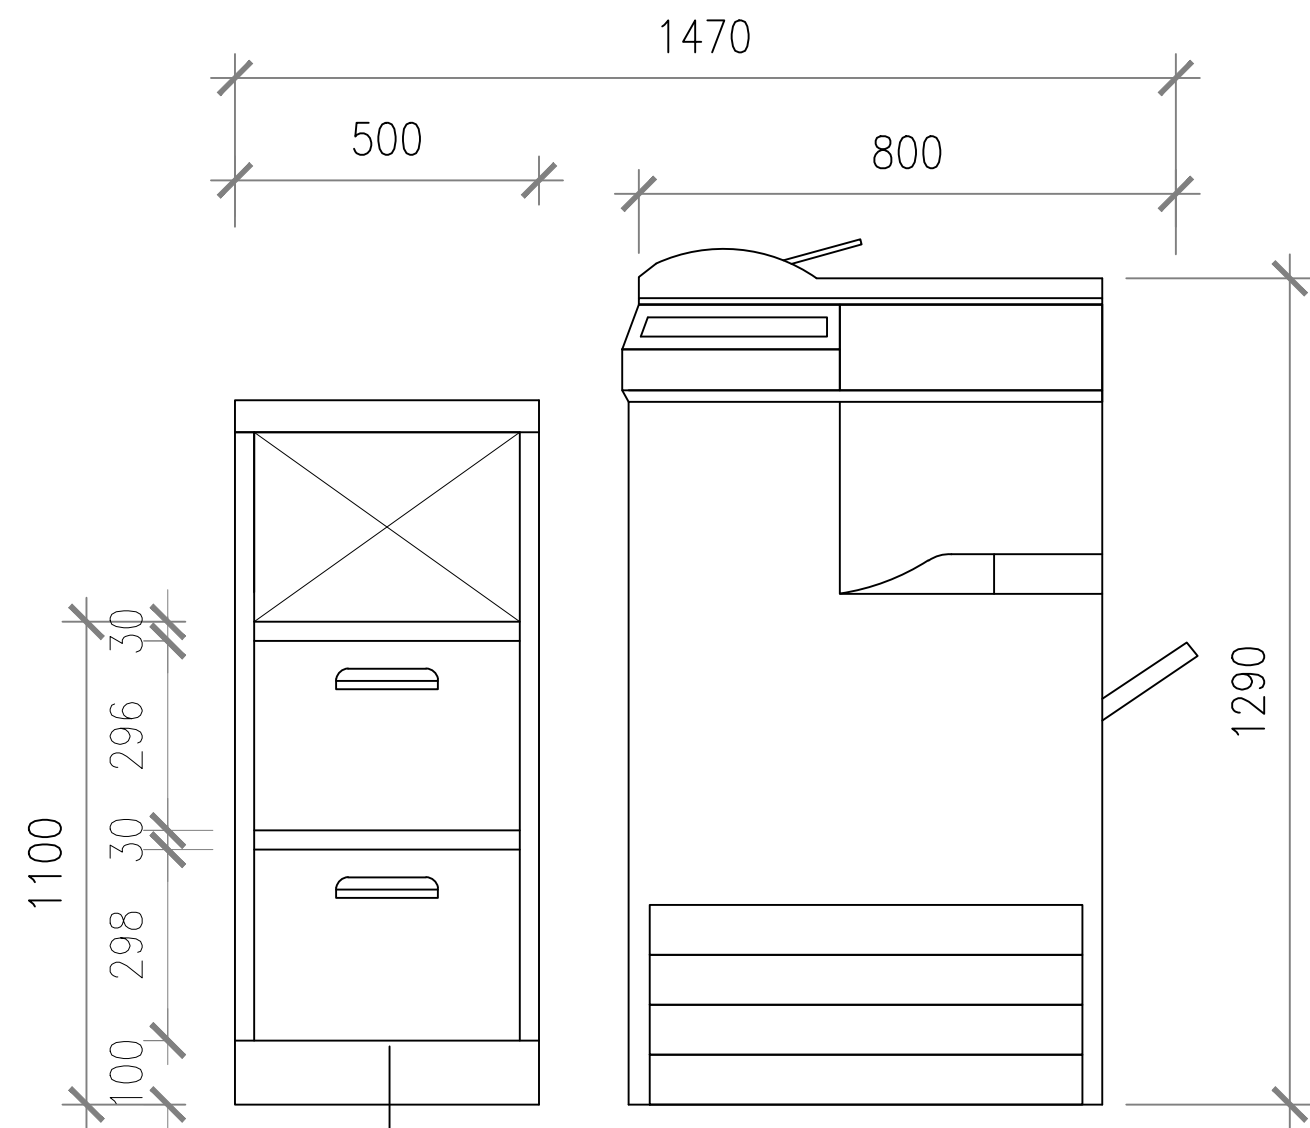

MAICA LAMINATE DIAMOND
COLLECTION M32400
LUMINOUS ASH

PRINTING STATION 11 ELEVATION A
SCALE : 1:30

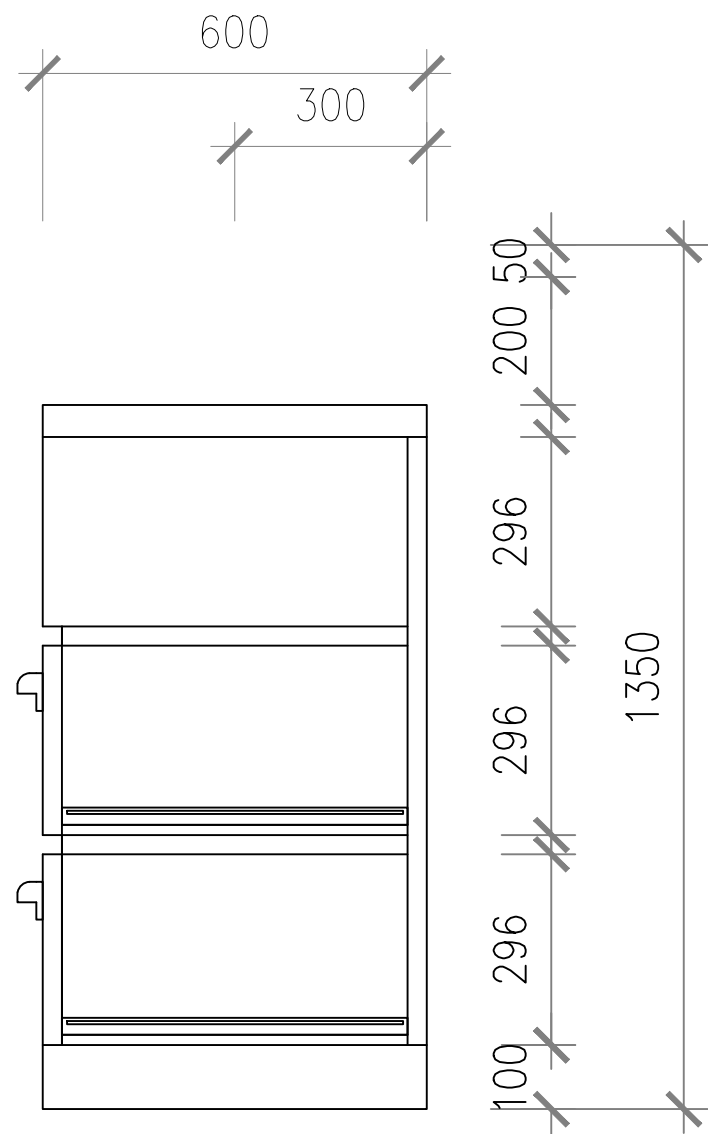

PRINTING STATION 11 ELEVATION B
SCALE : 1:30

Client / Developer :



PUTRAJAYA HOLDINGS
PUTRAJAYA HOLDINGS SDN. BHD (co.No.364152-K)
BLOK 1, MENARA SERI WILAYAH, PRECINCT 2
62100 PUTRAJAYA
TEL : 03-8883 8888 FAX : 03-8889 5499

Design & Built Contractor :



CONTRACTORS IN-HOUSE CONSULTANT :

Architect :



JAFRI MERICAN ARCHITECT
1-3, JALAN DIBANG 58/41,
TAMAN SUNGAI BESI INDIA,
43000 SUNGAI BESI, SELANGOR
JALAN DIBANG 58/41,
TAMAN SUNGAI BESI INDIA,
43000 SUNGAI BESI, SELANGOR
TEL: 03-89419481 FAX : 03-89419482
E-mail : jafri@jmericanarchitect.com.my

Civil & Structure Engineer :

PERUNDING AZIZ, AZALI & TEE SDN. BHD.
NO. 9, JALAN KEMAR 2,
BANGSA PUCHONG JAYA,
47100 PUCHONG,
SELANGOR
TEL: 03-5882 7485/7385
FAX: 03-5882 4674

Mechanical & Electrical Engineer :

PERUNDING UNIREKA
NO. 15-16,
JALAN KEMAR 5,
BANGSA PUCHONG JAYA,
47100 PUCHONG,
SELANGOR
TEL: 03-89761768
FAX: 03-89761769
E-mail : unireka@gmail.com

Landscape Architect :

VERITAS LANDSCAPE SDN BHD
8-12-15, BLOCK 8, MEWA AVENUE 2,
12, JALAN YAP KIAN SENG,
50450 WILAYAH PERSEKUTUAN KUALA LUMPUR
TEL: +603 21639571 FAX: +603 21639570

Facade Consultant :

Aurecon Singapore (Pte.) Ltd.
No. 152-BEACH ROAD,
#2-02 GATEWAY EAST,
SINGAPORE 109771
TEL : +65 6256 6188
FAX : +65 6251 7188
E-mail : singapore@ap.aurecongroup.com

Quantity Surveyor :

KPK QUANTITY SURVEYORS (SEMENTAUNG) SDN BHD
18-6 & 18-7, BLOCK B, 18TH FLOOR MEGAN,
AVENUE 8, 12, JALAN YAP KIAN SENG,
50450 WILAYAH PERSEKUTUAN KUALA LUMPUR
TEL: +603 21668000 FAX: +603 21668228

Green Building Consultant :

Exergy Malaysia Sdn Bhd
198 & 218, JALAN 17 / 45, 46400 PETALING JAYA,
SELANGOR DARUL EHSAN
TEL: +603 79583655 FAX: +603 79583660

Project Title :

CADANGAN UBAHSUAI
TEMPAT KERJA JABAT
MENARA PJH TINGKAT 10
PEMBANGUNAN 3 BLOK
UNTUK:
UNITED NATIONS MALAYSIA

Drawing Title :

PRINTING STATION P11 DETAILS

Electrical Contractor :

OMEGA ELECTRICAL
D'ALMANA SHOPLOT
UNIT NO. 2-01-01-01/02/03/04,
JALAN PUEU ULU CHEWAS,
56100 KUALA LUMPUR

Signature of Client / Developer :

.....
IR AUBREY M. SHEPHERDSON
HEAD OF DEPARTMENT, COMMERCIAL BUILDING
PUTRAJAYA HOLDINGS SDN. BHD (co.No.364152-K)
Blok 1, Menara Seri Wilayah, Precinct 2
62100 Putrajaya
Tel : 03-8883 8888 Fax : 03-8889 5499

Signature of M&E :

.....

Contract No. :

.....

No. Lukisan :

.....

.....

.....

.....

.....


.....

.....


.....

.....

P12

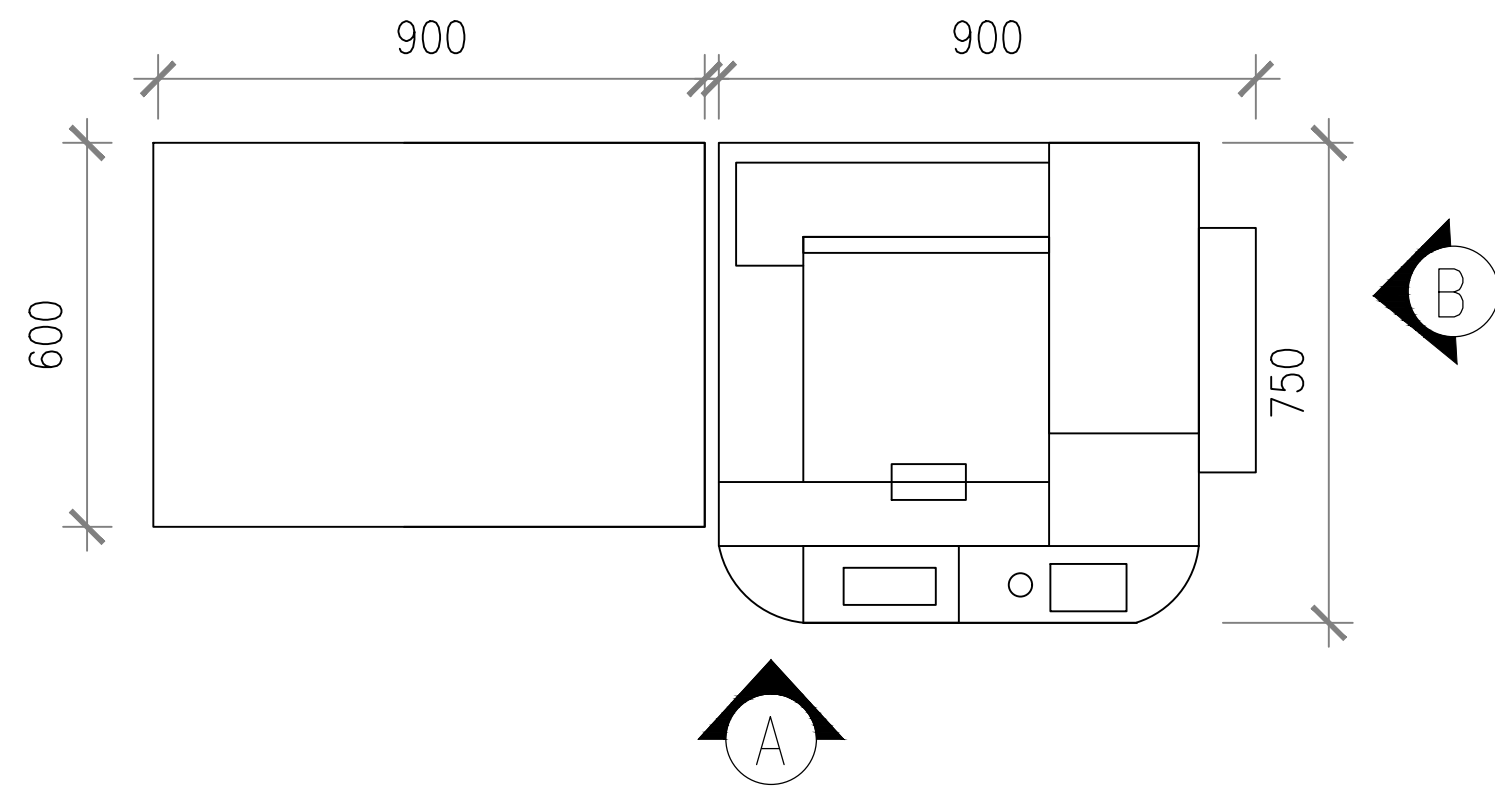


PRINTING STATION 11 TOP VIEW
SCALE : 1:30

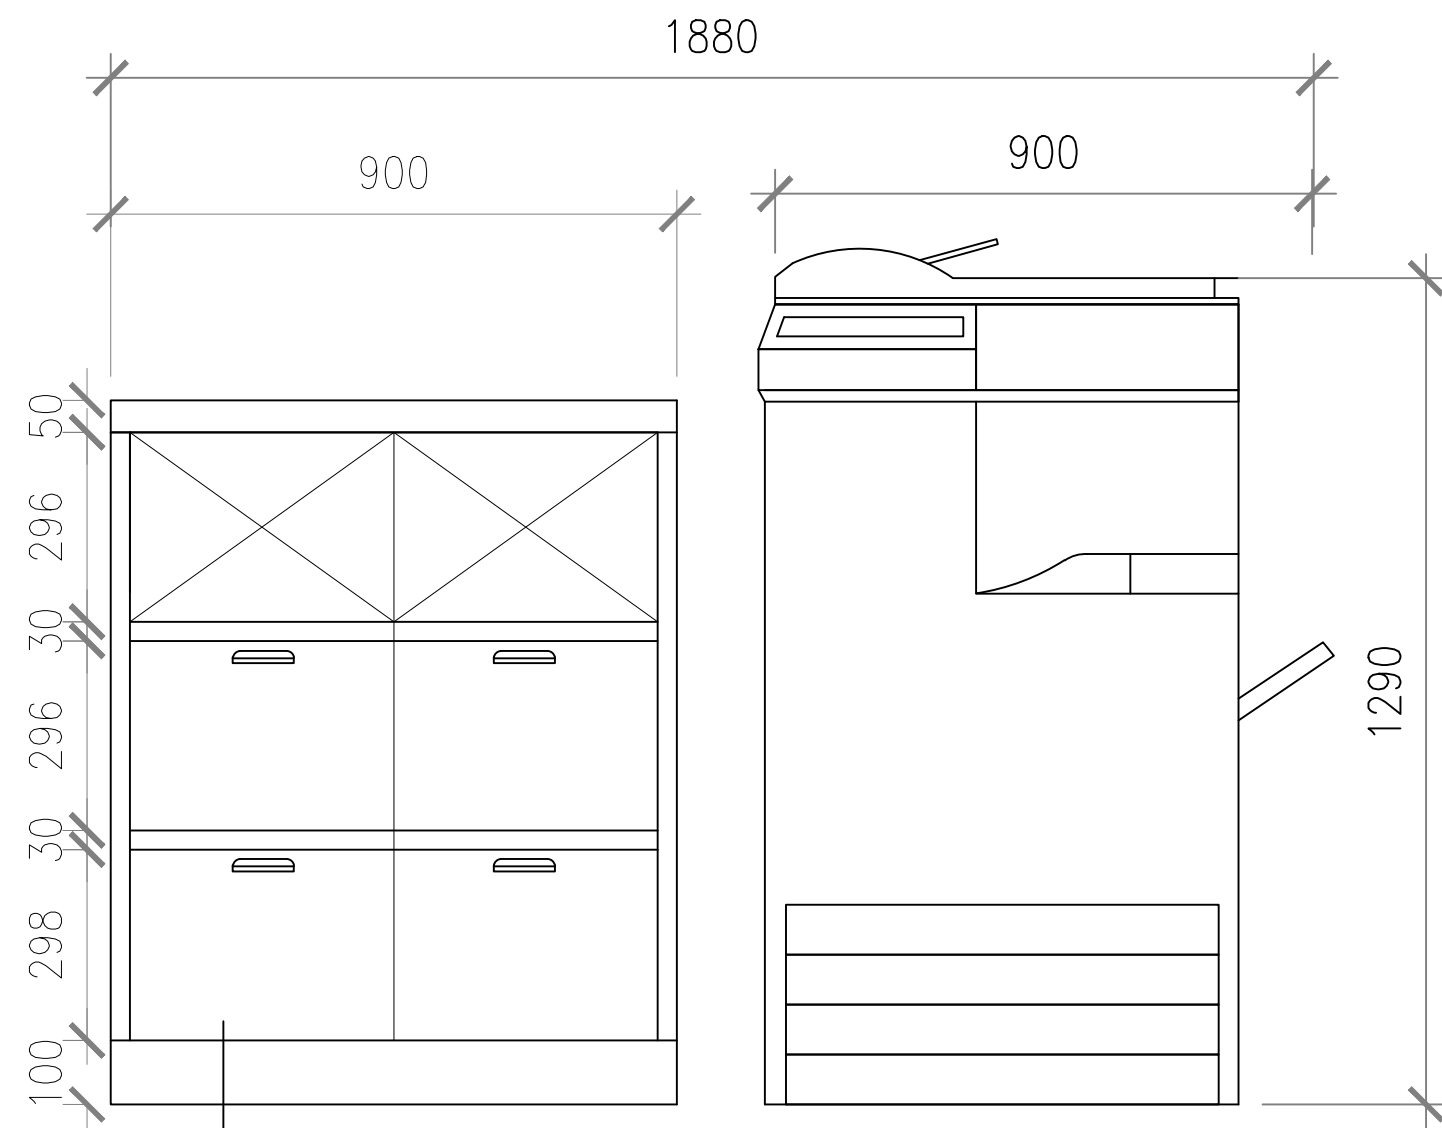

MAICA LAMINATE DIAMOND
COLLECTION M32400
LUMINOUS ASH

PRINTING STATION 12 ELEVATION A
SCALE : 1:30

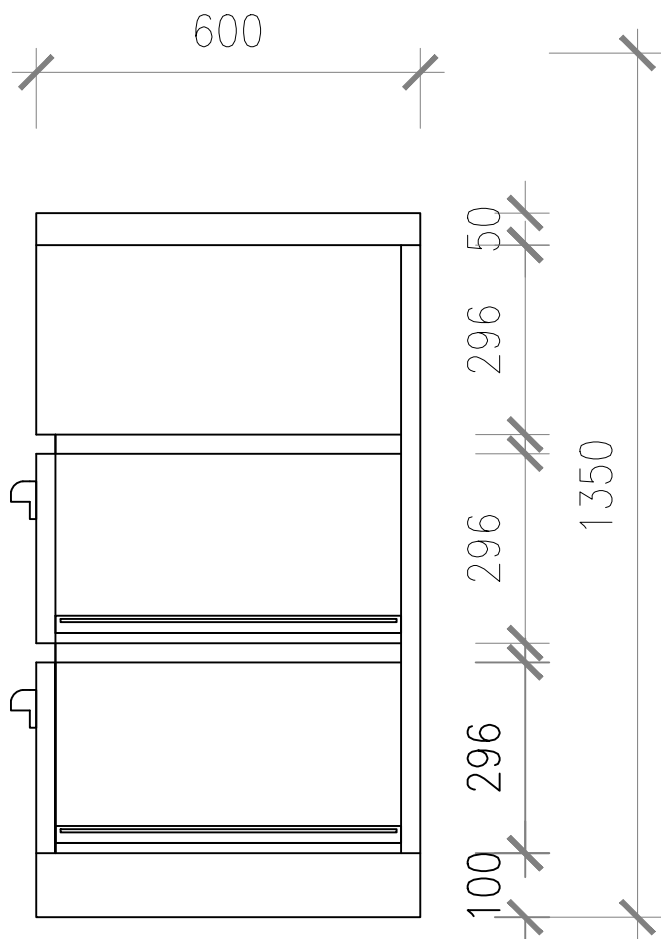

PRINTING STATION 12 ELEVATION B
SCALE : 1:30

Client / Developer :

PUTRAJAYA HOLDINGS
PUTRAJAYA HOLDINGS SDN. BHD (co.No.364152-K)
BLOK 1, MENARA SERI WILAYAH, PRECINCT 2
62100 PUTRAJAYA
TEL : 03-8883 8888 FAX : 03-8889 5499

Design & Built Contractor :

SPACE SPACE

CONTRACTORS IN-HOUSE CONSULTANT :

Architect :

JAFRI MERICAN ARCHITECT
11-3, JALAN BERING 28 4/1,
TAMAN SUNGAI BESI INDAH,
43300 SUNGAI KEMANG, SELANGOR
MALAYSIA
TEL: 03-89419481 FAX : 03-89419482
E-mail : jafri@jmericanarchitect.com.my

Civil & Structure Engineer :

PERUNDING AZIZ, AZALI & TEE SDN. BHD.
NO. 9, JALAN KEMAR 2,
BANGSA PUCHONG JAYA,
47100 PUCHONG,
SELANGOR
TEL: 03-5882 7485/7385
FAX: 03-5882 4674

Mechanical & Electrical Engineer :

PERUNDING UNIREKA
NO. 15-16,
JALAN KEMAR 5,
BANGSA PUCHONG JAYA,
47100 PUCHONG,
SELANGOR
TEL: 03-89761769
E-mail : unireka@gmail.com

Landscape Architect :

VERITAS LANDSCAPE SDN BHD
8-12-15, BLOCK B, MEWA AVENUE 2,
12, JALAN YAP KIAN SENG,
50450 WILAYAH PERSEKUTUAN KUALA LUMPUR
TEL: +603 21636971 FAX: +603 21636970

Facade Consultant :

Aurecon Singapore (Pte.) Ltd.
No. 152-BEACH ROAD,
#22-02 GATEWAY EAST,
SINGAPORE 189772
TEL : +65 6256 6188
FAX : +65 6251 7188
E-mail : singapore@ap.aurecongroup.com

Quantity Surveyor :

KPK
KPK QUANTITY SURVEYORS (SEMEPAJUNG) SDN BHD
18-6 & 18-7, BLOCK B, 18TH FLOOR MEGAN,
AVENUE 12, JALAN YAP KIAN SENG,
50450 WILAYAH PERSEKUTUAN KUALA LUMPUR
TEL: +603 21668000 FAX: +603 21668228

Green Building Consultant :

Exergy Malaysia Sdn Bhd
198 & 218, JALAN 17 / 45, 46400 PETALING JAYA,
SELANGOR DARUL EHSAN,
TEL: +603 79583655 FAX: +603 79583660

Project Title :

**CADANGAN UBAHSUAI
TEMPAT KERJA JABAT
MENARA PJH TINGKAT 10
PEMBANGUNAN 3 BLOK**

**UNTUK:
UNITED NATIONS MALAYSIA**

Drawing Title :

PRINTING STATION P12 DETAILS

Electrical Contractor :

OMEGA ELECTRICAL
D'ALAMBA SHOPLOT
UNIT NO. 2-01-1-201-202
JALAN PUDU ULU CHEONG,
56100 KUALA LUMPUR

Signature of Client / Developer :

.....
IR AUBREY M. SHEPHERDSON
HEAD OF DEPARTMENT, COMMERCIAL BUILDING
PUTRAJAYA HOLDINGS SDN. BHD (co.No.364152-K)
Blok 1, Menara Seri Wilayah, Precinct 2
62100 Putrajaya
Tel : 03-8883 8888 Fax : 03-8889 5499

Signature of M&E :

Contract No. :

No. Lukisan :

Drawn By	Date
JJ	OCT 2017
Check By	Date
DAREN WONG	OCT 2017
Scale	
1 : 30	

Drawings No. :

Revision No.	Date	Notes	Status: