

OWNER:

دائرة الأوقاف الإسلامية في القدس



PROJECT TITLE:

PRODUCTIVITY AND URBAN RENEWAL IN EAST JERUSALEM
(PURE)

Renovation Works of Buildings SS001

JERUSALEM

CONSULTANTS:



November 2017

OWNER:

دائرة الأوقاف الإسلامية في القدس



PROJECT TITLE:

PRODUCTIVITY AND URBAN RENEWAL IN EAST JERUSALEM
(PURE)

Renovation Works of Buildings SD001


Architectural Drawings

ARCHITECTURAL SHEETS LIST	
SHEET NUMBER	SHEET NAME
A0-01	Site Plan
A1-01	Ground Floor Plan
A1-02	Mezzanine Floor Plan
A1-03	First Floor Plan
A1-04-A	Roof Plan (Interventions)
A1-04-B	Roof Plan (Proposed)
A1-05	Rain Water Drainage
A2-01	Street Front Elevation (1)
A2-02	Side Elevations (2&3)
A6-01	Doors & Windows Schedules

دائرة الأوقاف الإسلامية في القدس

UNDP
United Nations
Development
Programme

EUROPEAN UNION

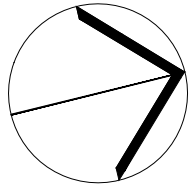

NORTH

03			
02			
01			
REV.	SUBJECT	DATE	BY

NOTES:
- All Levels in meter
- All dimensions are shown in centimeters.
.....
.....

LEGEND:

1- REINFORCED CONCRETE

2- CONCRETE

3- STONE

4- CONCRETE BLOCK

5- YTONG BLOCK

5- BASE COURSE

6- SAND

7- COMPACTED FILL OR NATURAL GROUND

8- LEVEL SYMBOL (PLAN)

10- LEVEL SYMBOL (SECTION - ELEVATION)

11- FINISH FLOOR LEVEL

12- CONCRETE FLOOR LEVEL

13- WINDOW LABEL

14- DOOR LABEL

15- DETAILS SIGN

16- STRUCTURAL SYMBOLS - COLUMNS

1- EXISTING COLUMN

2- RC COLUMN

3- COLUMN CONCRETE JACKETING

4- COLUMN STEEL JACKETING

* REF TO STRUCTURE DRAWINGS TO GET FINAL DATA

PROJECT TITLE

PRODUCTIVITY& URBAN RENEWAL
IN EAST JERUSALEM (PURE)

RENOVATION WORKS OF
BUILDING SS001

SHEET TITLE:

INDEX

CONSULTANTS:

ZIADAH
ARCHITECTS & ENGINEERS
معماريون وهندسون

DOUR
ENGINEERING & PLANNING
CONSULTING ENGINEERS

Scale :
1:100 When Printed At Sheet (A3)

Date :
02/11/2017

Design by :
ZIADAH CONSULTANTS




checked by:
ZIADAH CONSULTANTS

Division :
ARCHITECTURAL


Drawn by:
ZIADAH CONSULTANTS

SHEET NO.
A0-00

Project No. 21/16

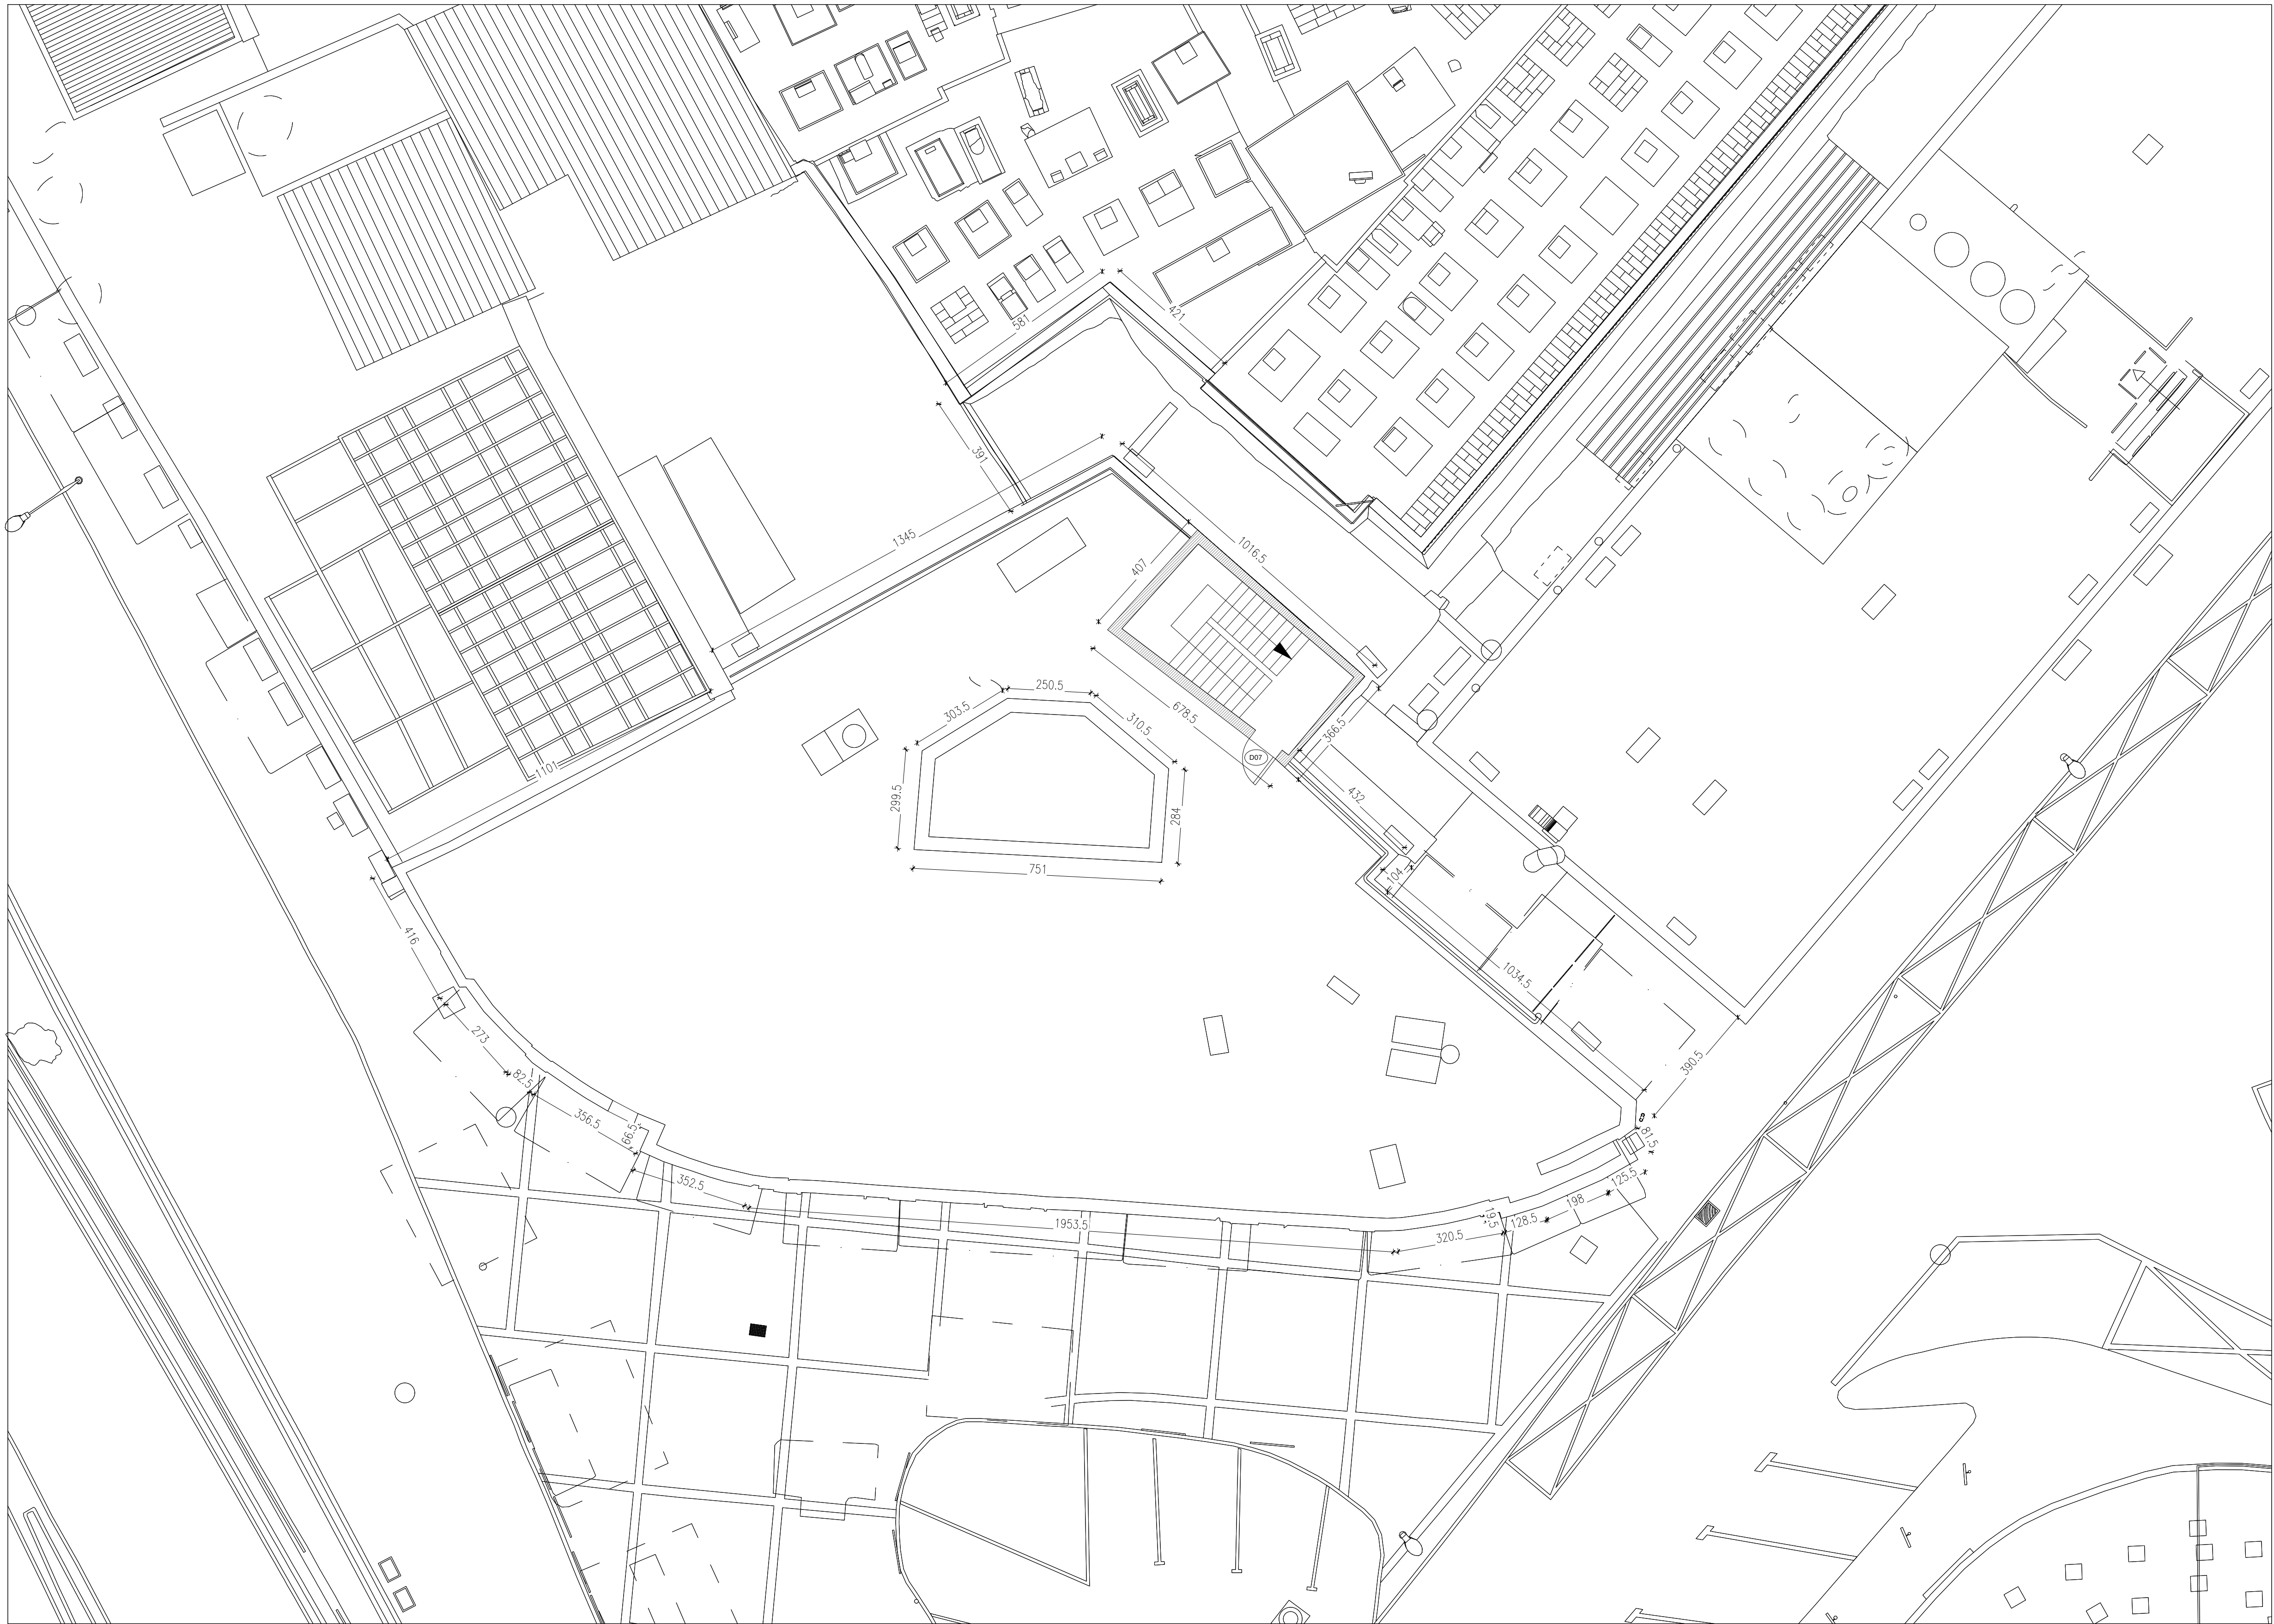

دائرة الأوقاف الإسلامية في القدس

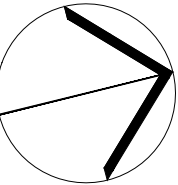

03			
02			
01			
REV.	SUBJECT	DATE	BY

NOTES:
- All Levels in meter
- All dimensions are shown in centimeters.


LEGEND:	
1- REINFORCED CONCRETE	
2- CONCRETE	
3- STONE	
4- CONCRETE BLOCK	
5- YTONG BLOCK	
6- BASE COURSE	
7- SAND	
8- COMPACTED FILL OR NATURAL GROUND	
9- LEVEL SYMBOL (PLAN)	
10- LEVEL SYMBOL (SECTION - ELEVATION)	
11- FINISH FLOOR LEVEL	
12- CONCRETE FLOOR LEVEL	
13- WINDOW LABEL	
14- DOOR LABEL	
15- DETAILS SIGN	
16- STRUCTURAL SYMBOLS - COLUMNS	
1- EXISTING COLUMN	
2- RC COLUMN	
3- COLUMN CONCRETE JACKETING	
4- COLUMN STEEL JACKETING	
* REF TO STRUCTURE DRAWINGS TO GET FINAL DATA	

PROJECT TITLE
PRODUCTIVITY& URBAN RENEWAL
IN EAST JERUSALEM (PURE)
RENOVATION WORKS OF
BUILDING SS001

SHEET TITLE:
Site Plan

CONSULTANTS:
ZIADAH
ARCHITECTS & ENGINEERS
مهندسون وعلماء
DOOR
ENGINEERING & PLANNING
CONSULTING ENGINEERS

Scale : 1:100 When Printed At Sheet (A1)	Date : 02/11/2017
Design by : ZIADAH CONSULTANTS	
checked by : ZIADAH CONSULTANTS	Division : ARCHITECTURAL
Drawn by : ZIADAH CONSULTANTS	SHEET NO. A0-01
Project No. : 21/16	

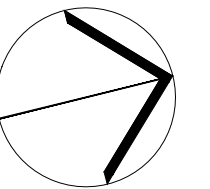

03			
02			
01			
REV.	SUBJECT	DATE	BY

NOTES:

- All Levels in meter
- All dimensions are shown in centimeters.

.....

.....

LEGEND:

- | | |
|--|---|
| 1- REINFORCED CONCRETE |  |
| 2- CONCRETE |  |
| 3- STONE |  |
| 4- CONCRETE BLOCK |  |
| 5- YTONG BLOCK |  |
| 5- BASE COURSE |  |
| 6- SAND |  |
| 7- COMPACTED FILL OR NATURAL GROUND |  |
| 8- LEVEL SYMBOL (PLAN) |  <div style="display: inline-block; vertical-align: middle; margin-left: 10px;"> ± 0.00 F.F.L.
 -0.12 C.F.L. </div> |
| 10- LEVEL SYMBOL (SECTION - ELEVATION) |  <div style="display: inline-block; vertical-align: middle; margin-left: 10px;"> ± 0.00 F.F.L.
 C.F.L. </div> |
| 12- CONCRETE FLOOR LEVEL |  |
| 13- WINDOW LABEL | <div style="display: flex; align-items: center;"> <div style="margin-right: 10px;">WINDOW NUMBER</div>  </div> |
| 14- DOOR LABEL | <div style="display: flex; align-items: center;"> <div style="margin-right: 10px;">DOOR NUMBER</div>  </div> |
| 15- DETAILS SIGN | <div style="display: flex; align-items: center;"> <div style="margin-right: 10px;">ELEVATION</div>  <div style="margin-left: 10px;">SECTION #</div> <div style="margin-left: 10px;">SHEET #</div> </div> |
| 16- STRUCTURAL SYMBOLS - COLUMNS | |
| 1- EXISTING COLUMN |  |
| 2- RC COLUMN |  |
| 3- COLUMN CONCRETE JACKETING |  |
| 4- COLUMN STEEL JACKETING |  |
- * REF TO STRUCTURE DRAWINGS TO GET FINAL DATA

PROJECT TITLE

PRODUCTIVITY & URBAN RENEWAL IN EAST JERUSALEM (PURE)

RENOVATION WORKS OF BUILDING SS001

SHEET TITLE:


Ground Floor Plan

CONSULTANTS:


ZIADAH
ARCHITECTS & ENGINEERS
معماريون ومهندسون



Scale :	Date :
1:100 When Printed A1 Sheet (A1)	02/11/2017
Design by :	

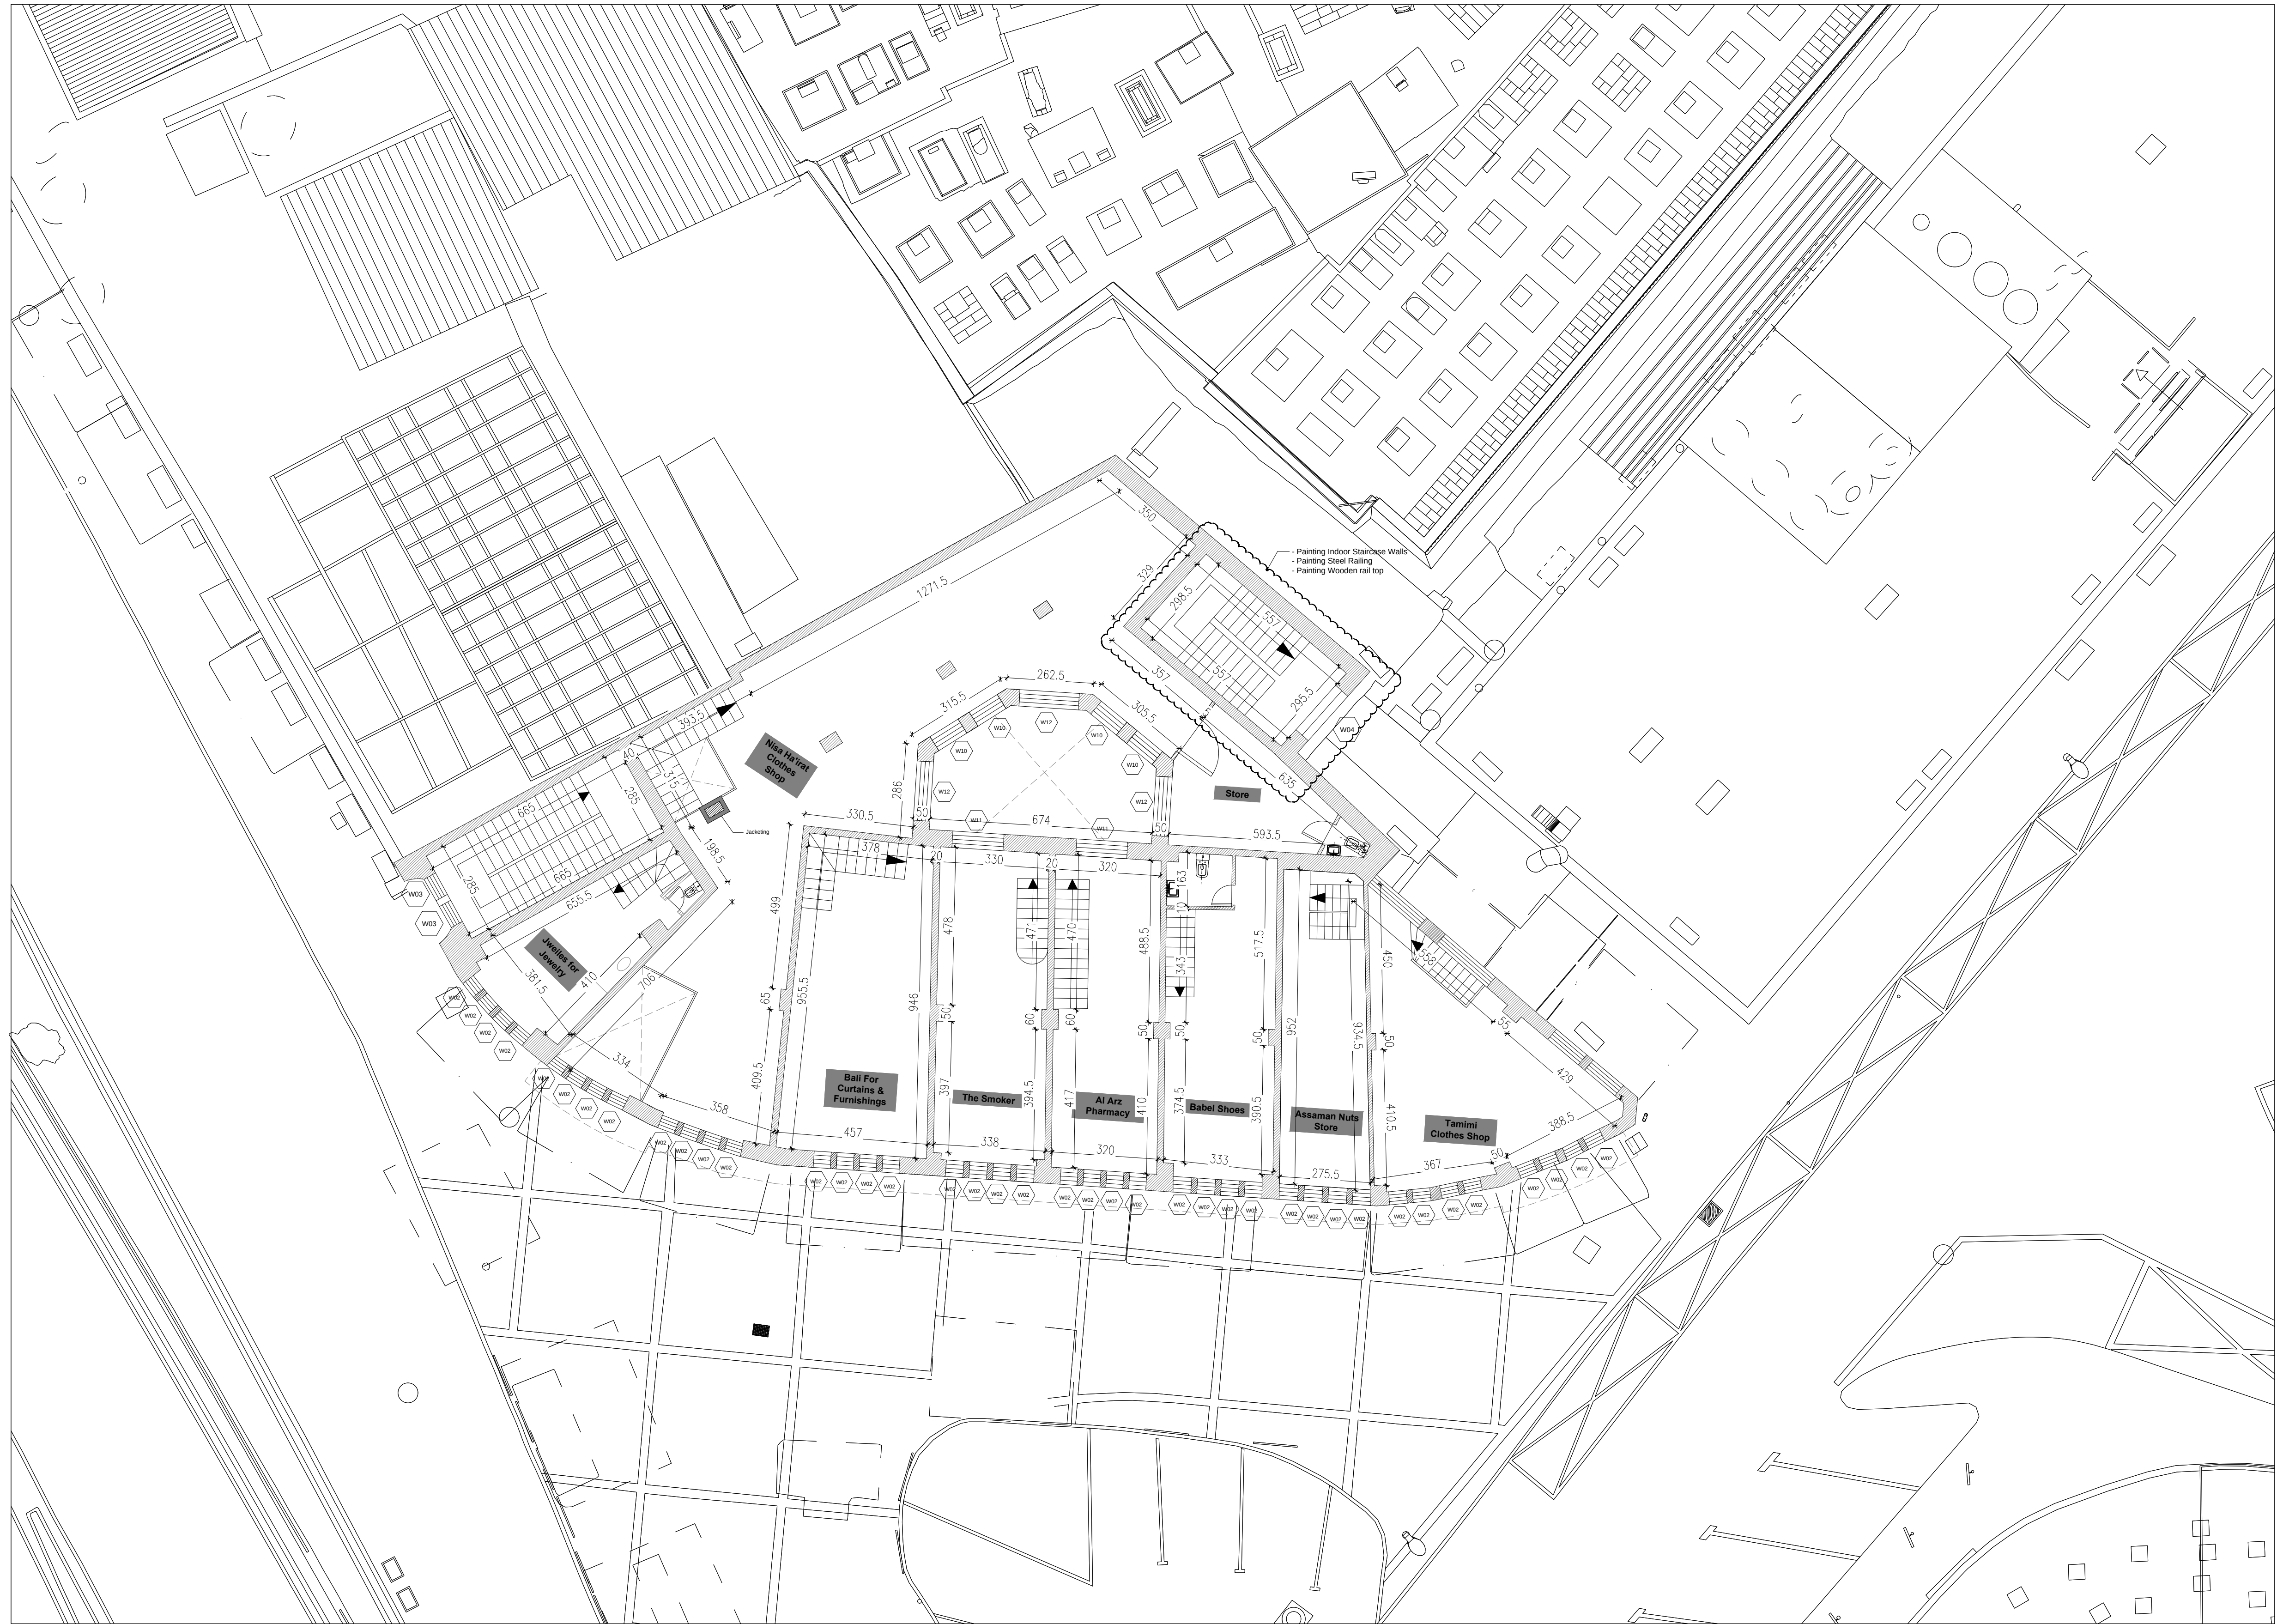

دائرة الأوقاف الإسلامية في القدس

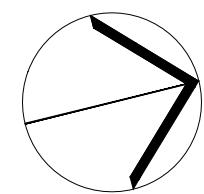

NORTH

03			
02			
01			
REV.	SUBJECT	DATE	BY

NOTES:
- All Levels in meter
- All dimensions are shown in centimeters.


LEGEND:	
1- REINFORCED CONCRETE	
2- CONCRETE	
3- STONE	
4- CONCRETE BLOCK	
5- YTONG BLOCK	
6- BASE COURSE	
7- SAND	
8- COMPACTED FILL OR NATURAL GROUND	
9- LEVEL SYMBOL (PLAN)	±0.00 F.F.L. -0.12 C.F.L.
10- LEVEL SYMBOL (SECTION - ELEVATION)	±0.00
11- FINISH FLOOR LEVEL	F.F.L.
12- CONCRETE FLOOR LEVEL	C.F.L.
13- WINDOW LABEL	WINDOW NUMBER W1
14- DOOR LABEL	DOOR NUMBER D1
15- DETAILS SIGN	ELEVATION # SECTION # SHEET #
16- STRUCTURAL SYMBOLS - COLUMNS	
1- EXISTING COLUMN	
2- RC COLUMN	
3- COLUMN CONCRETE JACKETING	
4- COLUMN STEEL JACKETING	
* REF TO STRUCTURE DRAWINGS TO GET FINAL DATA	

PROJECT TITLE
PRODUCTIVITY & URBAN RENEWAL
IN EAST JERUSALEM (PURE)
RENOVATION WORKS OF
BUILDING SS001


SHEET TITLE:
Mezzanine Floor Plan

CONSULTANTS:
ZIADAH
ARCHITECTS & ENGINEERS
مهندسون وعلماء
DOUR
ENGINEERING & PLANNING
مهندسون وعلماء

Scale : 1:100 When Printed At Sheet (A1)	Date : 02/11/2017
Design by : ZIADAH CONSULTANTS	Division : ARCHITECTURAL
checked by : ZIADAH CONSULTANTS	SHEET NO. A1-02
Drawn by : ZIADAH CONSULTANTS	
Project No. : 21/16	

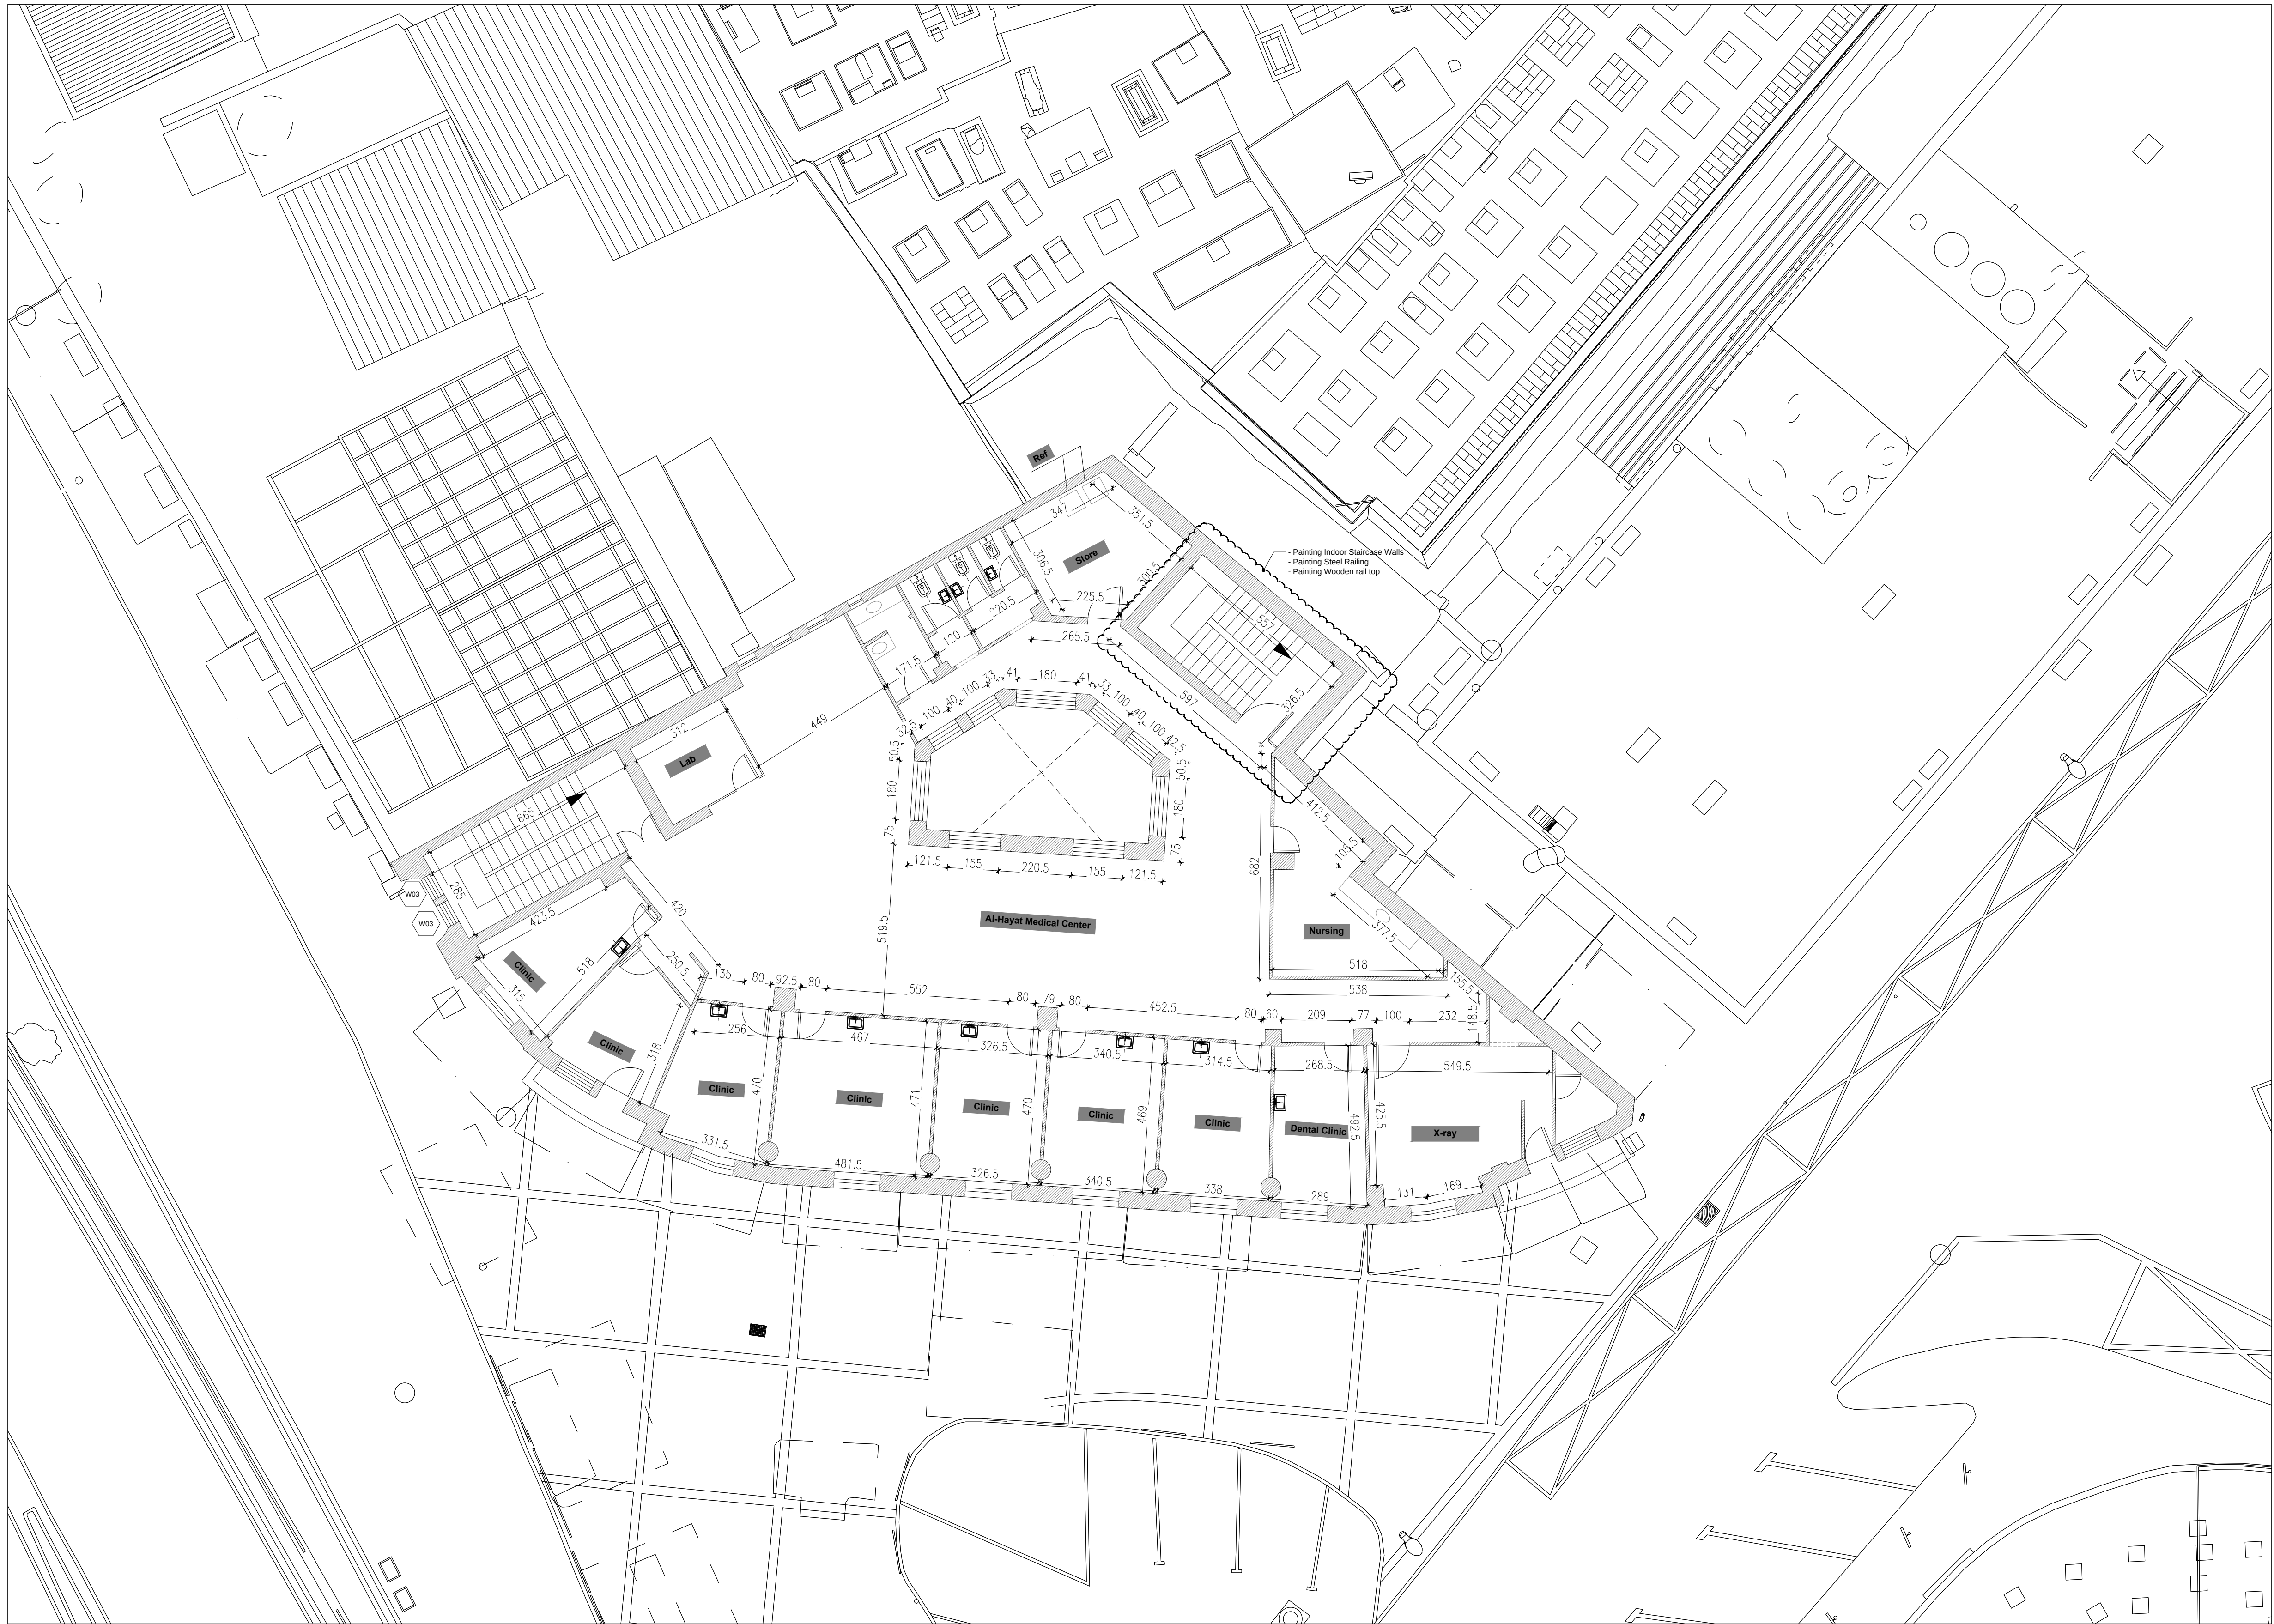

دائرة الأوقاف الإسلامية في القدس

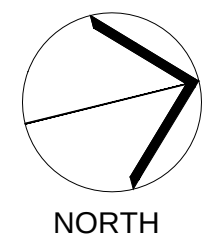

03			
02			
01			
REV.	SUBJECT	DATE	BY

NOTES:
- All Levels in meter
- All dimensions are shown in centimeters.


LEGEND:	
1- REINFORCED CONCRETE	
2- CONCRETE	
3- STONE	
4- CONCRETE BLOCK	
5- YTONG BLOCK	
6- SAND	
7- COMPACTED FILL OR NATURAL GROUND	
8- LEVEL SYMBOL (PLAN)	±0.00 F.F.L. -0.12 C.F.L.
10- LEVEL SYMBOL (SECTION - ELEVATION)	±0.00 F.F.L. C.F.L.
11- FINISH FLOOR LEVEL	F.F.L.
12- CONCRETE FLOOR LEVEL	C.F.L.
13- WINDOW LABEL	WINDOW NUMBER W1
14- DOOR LABEL	DOOR NUMBER D1
15- DETAILS SIGN	ELEVATION # SECTION # SHEET #
16- STRUCTURAL SYMBOLS - COLUMNS	
1- EXISTING COLUMN	
2- RC COLUMN	
3- COLUMN CONCRETE JACKETING	
4- COLUMN STEEL JACKETING	
* REF TO STRUCTURE DRAWINGS TO GET FINAL DATA	

PROJECT TITLE
PRODUCTIVITY& URBAN RENEWAL
IN EAST JERUSALEM (PURE)
RENOVATION WORKS OF
BUILDING SS001

SHEET TITLE:
First Floor Plan


CONSULTANTS:
ZIADAH
ARCHITECTS & ENGINEERS
مهندسين معماريين ومهندسين
DOUR
ENGINEERING & PLANNING
مهندسين معماريين ومهندسين

Scale : 1:100 When Printed At Sheet (A1)	Date : 02/11/2017
Design by : ZIADAH CONSULTANTS	Division : ARCHITECTURAL
checked by : ZIADAH CONSULTANTS	SHEET NO. A1-03
Drawn by : ZIADAH CONSULTANTS	
Project No. : 21/16	

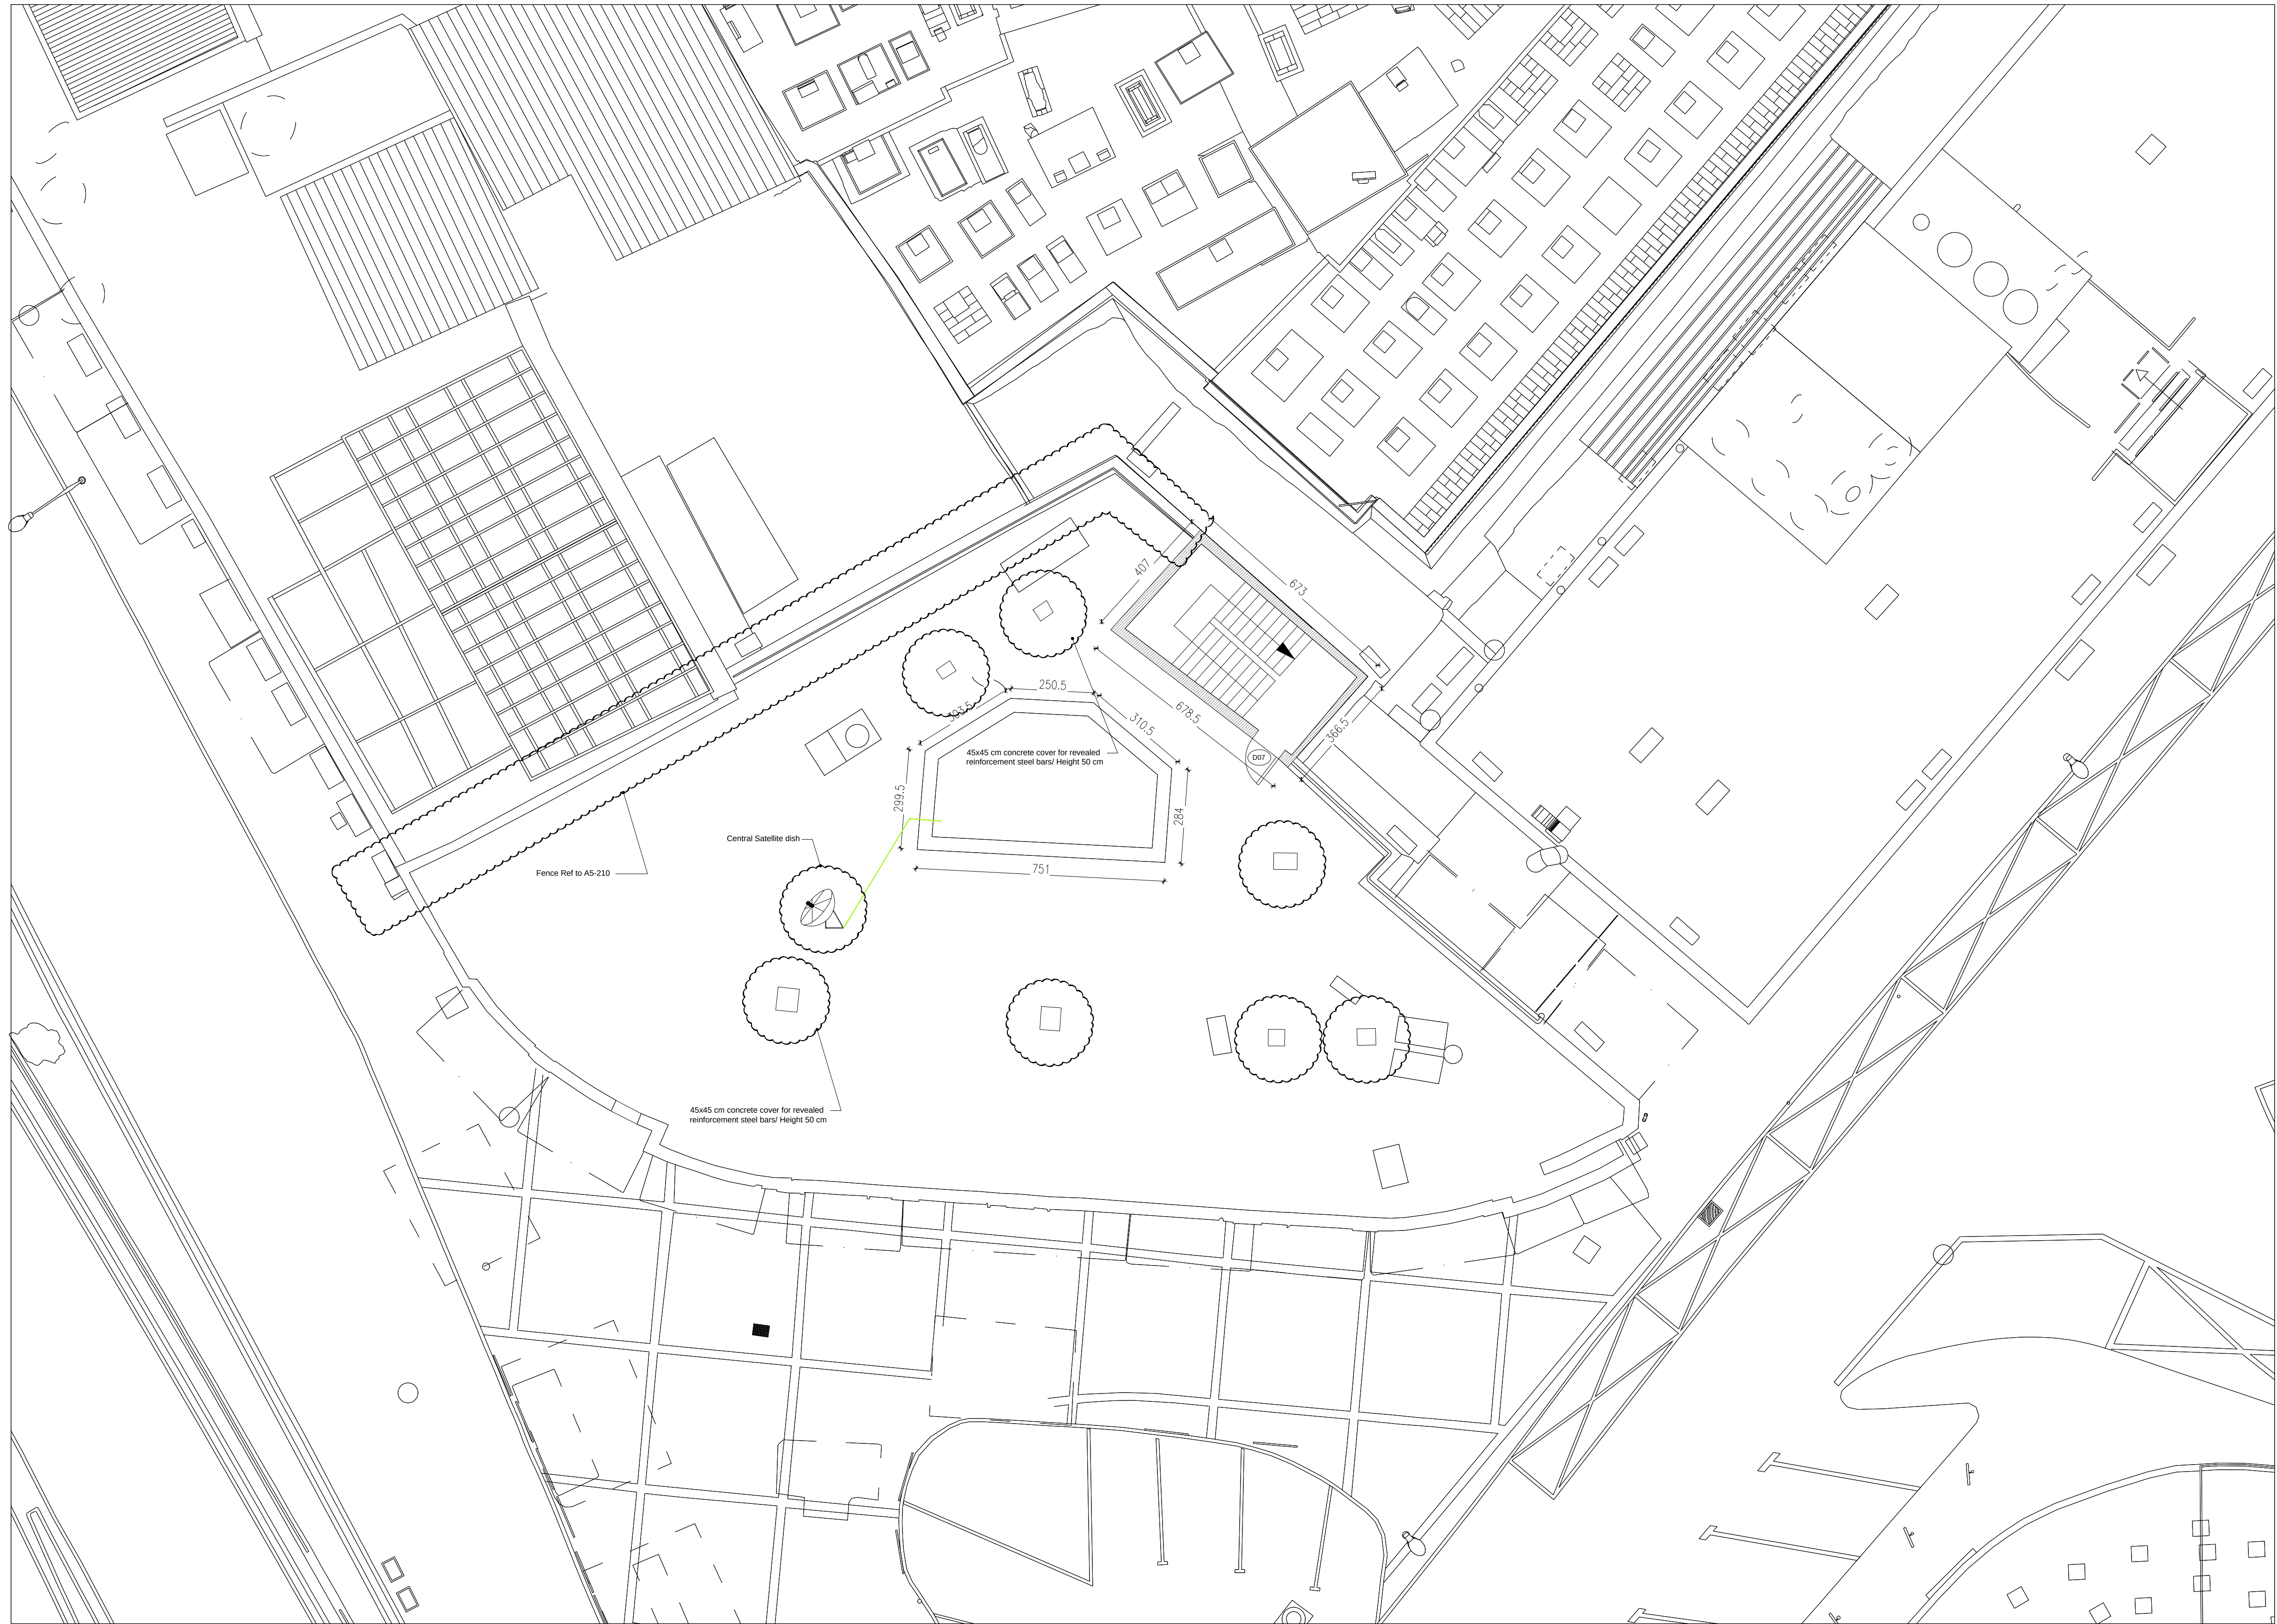

1 Roof Plan (INTERVENTIONS)
1:100

دائرة الأوقاف الإسلامية في القدس

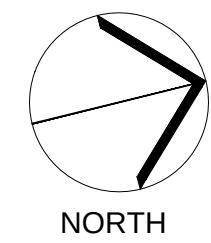

03			
02			
01			
REV.	SUBJECT	DATE	BY

NOTES:
- All Levels in meter
- All dimensions are shown in centimeters.

LEGEND:	
1- REINFORCED CONCRETE	
2- CONCRETE	
3- STONE	
4- CONCRETE BLOCK	
5- YTONG BLOCK	
6- BASE COURSE	
7- SAND	
8- COMPACTED FILL OR NATURAL GROUND	
9- LEVEL SYMBOL (PLAN)	
10- LEVEL SYMBOL (SECTION - ELEVATION)	
11- FINISH FLOOR LEVEL	
12- CONCRETE FLOOR LEVEL	
13- WINDOW LABEL	
14- DOOR LABEL	
15- DETAILS SIGN	
16- STRUCTURAL SYMBOLS - COLUMNS	
1- EXISTING COLUMN	
2- RC COLUMN	
3- COLUMN CONCRETE JACKETING	
4- COLUMN STEEL JACKETING	
* REF TO STRUCTURE DRAWINGS TO GET FINAL DATA	

PROJECT TITLE
PRODUCTIVITY& URBAN RENEWAL
IN EAST JERUSALEM (PURE)

RENOVATION WORKS OF
BUILDING SS001

SHEET TITLE:


Roof Floor Plan

CONSULTANTS:

ZIADAH
ARCHITECTS & ENGINEERS
معماريون ومهندسون


DOUR
ENGINEERING & PLANNING
مهندسون ومخططون

Scale : 1:100 When Printed At Sheet (A1)	Date : 02/11/2017
Design by : ZIADAH CONSULTANTS	
checked by : ZIADAH CONSULTANTS	Division : ARCHITECTURAL
Drawn by : ZIADAH CONSULTANTS	SHEET NO.
Project No. 21/16	A1-04-A

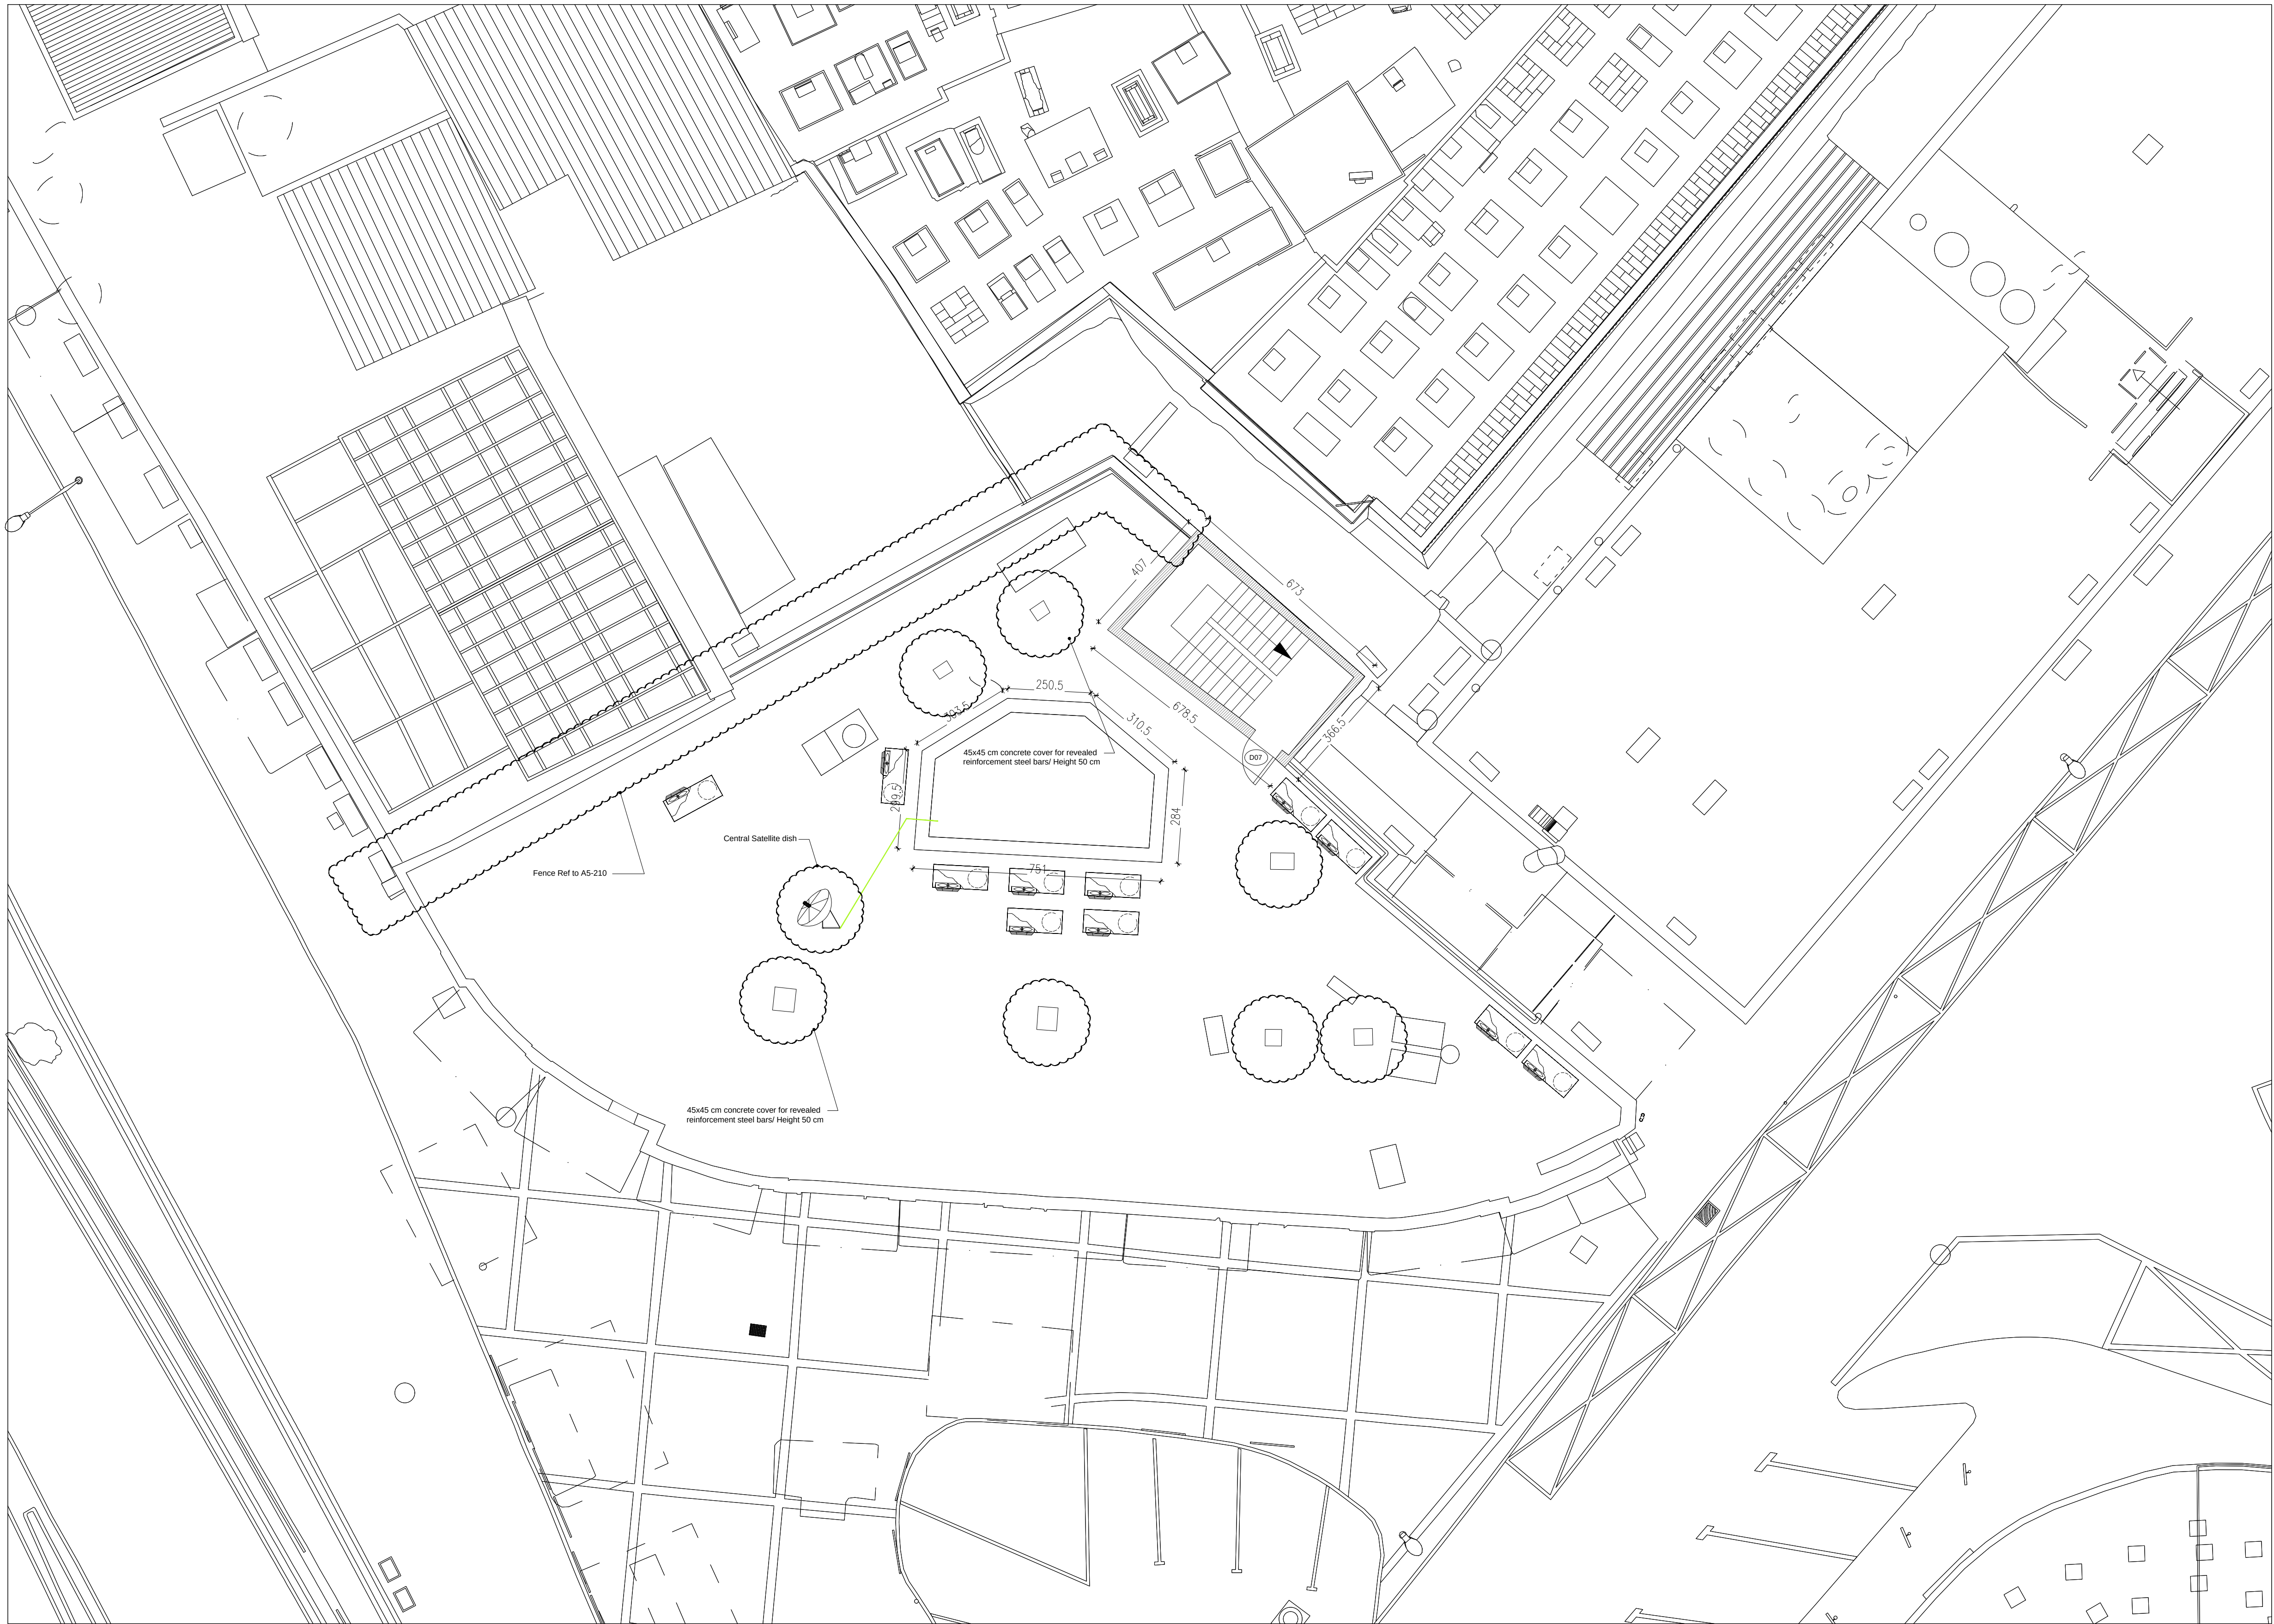

1 Roof Plan (PROPOSED)
1:100

دائرة الأوقاف الإسلامية في القدس

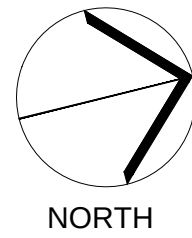

03			
02			
01			
REV.	SUBJECT	DATE	BY

NOTES:
- All Levels in meter
- All dimensions are shown in centimeters.


1- REINFORCED CONCRETE	
2- CONCRETE	
3- STONE	
4- CONCRETE BLOCK	
5- YTONG BLOCK	
6- BASE COURSE	
7- SAND	
8- COMPACTED FILL OR NATURAL GROUND	
9- LEVEL SYMBOL (PLAN)	
10- LEVEL SYMBOL (SECTION - ELEVATION)	
11- FINISH FLOOR LEVEL	
12- CONCRETE FLOOR LEVEL	
13- WINDOW LABEL	
14- DOOR LABEL	
15- DETAILS SIGN	
16- STRUCTURAL SYMBOLS - COLUMNS	
1- EXISTING COLUMN	
2- RC COLUMN	
3- COLUMN CONCRETE JACKETING	
4- COLUMN STEEL JACKETING	
* REF TO STRUCTURE DRAWINGS TO GET FINAL DATA	

PROJECT TITLE
PRODUCTIVITY& URBAN RENEWAL
IN EAST JERUSALEM (PURE)
RENOVATION WORKS OF
BUILDING SS001


SHEET TITLE:
Roof Floor Plan

CONSULTANTS:
ZIADAH
ARCHITECTS & ENGINEERS
معماريون ومهندسون
DOUR
ENGINEERING & PLANNING
CONSULTING ENGINEERS

Scale : 1:100 When Printed At Sheet (A1)	Date : 02/11/2017
Design by : ZIADAH CONSULTANTS	
checked by : ZIADAH CONSULTANTS	Division : ARCHITECTURAL
Drawn by : ZIADAH CONSULTANTS	SHEET NO.
Project No. 21/16	A1-04-B

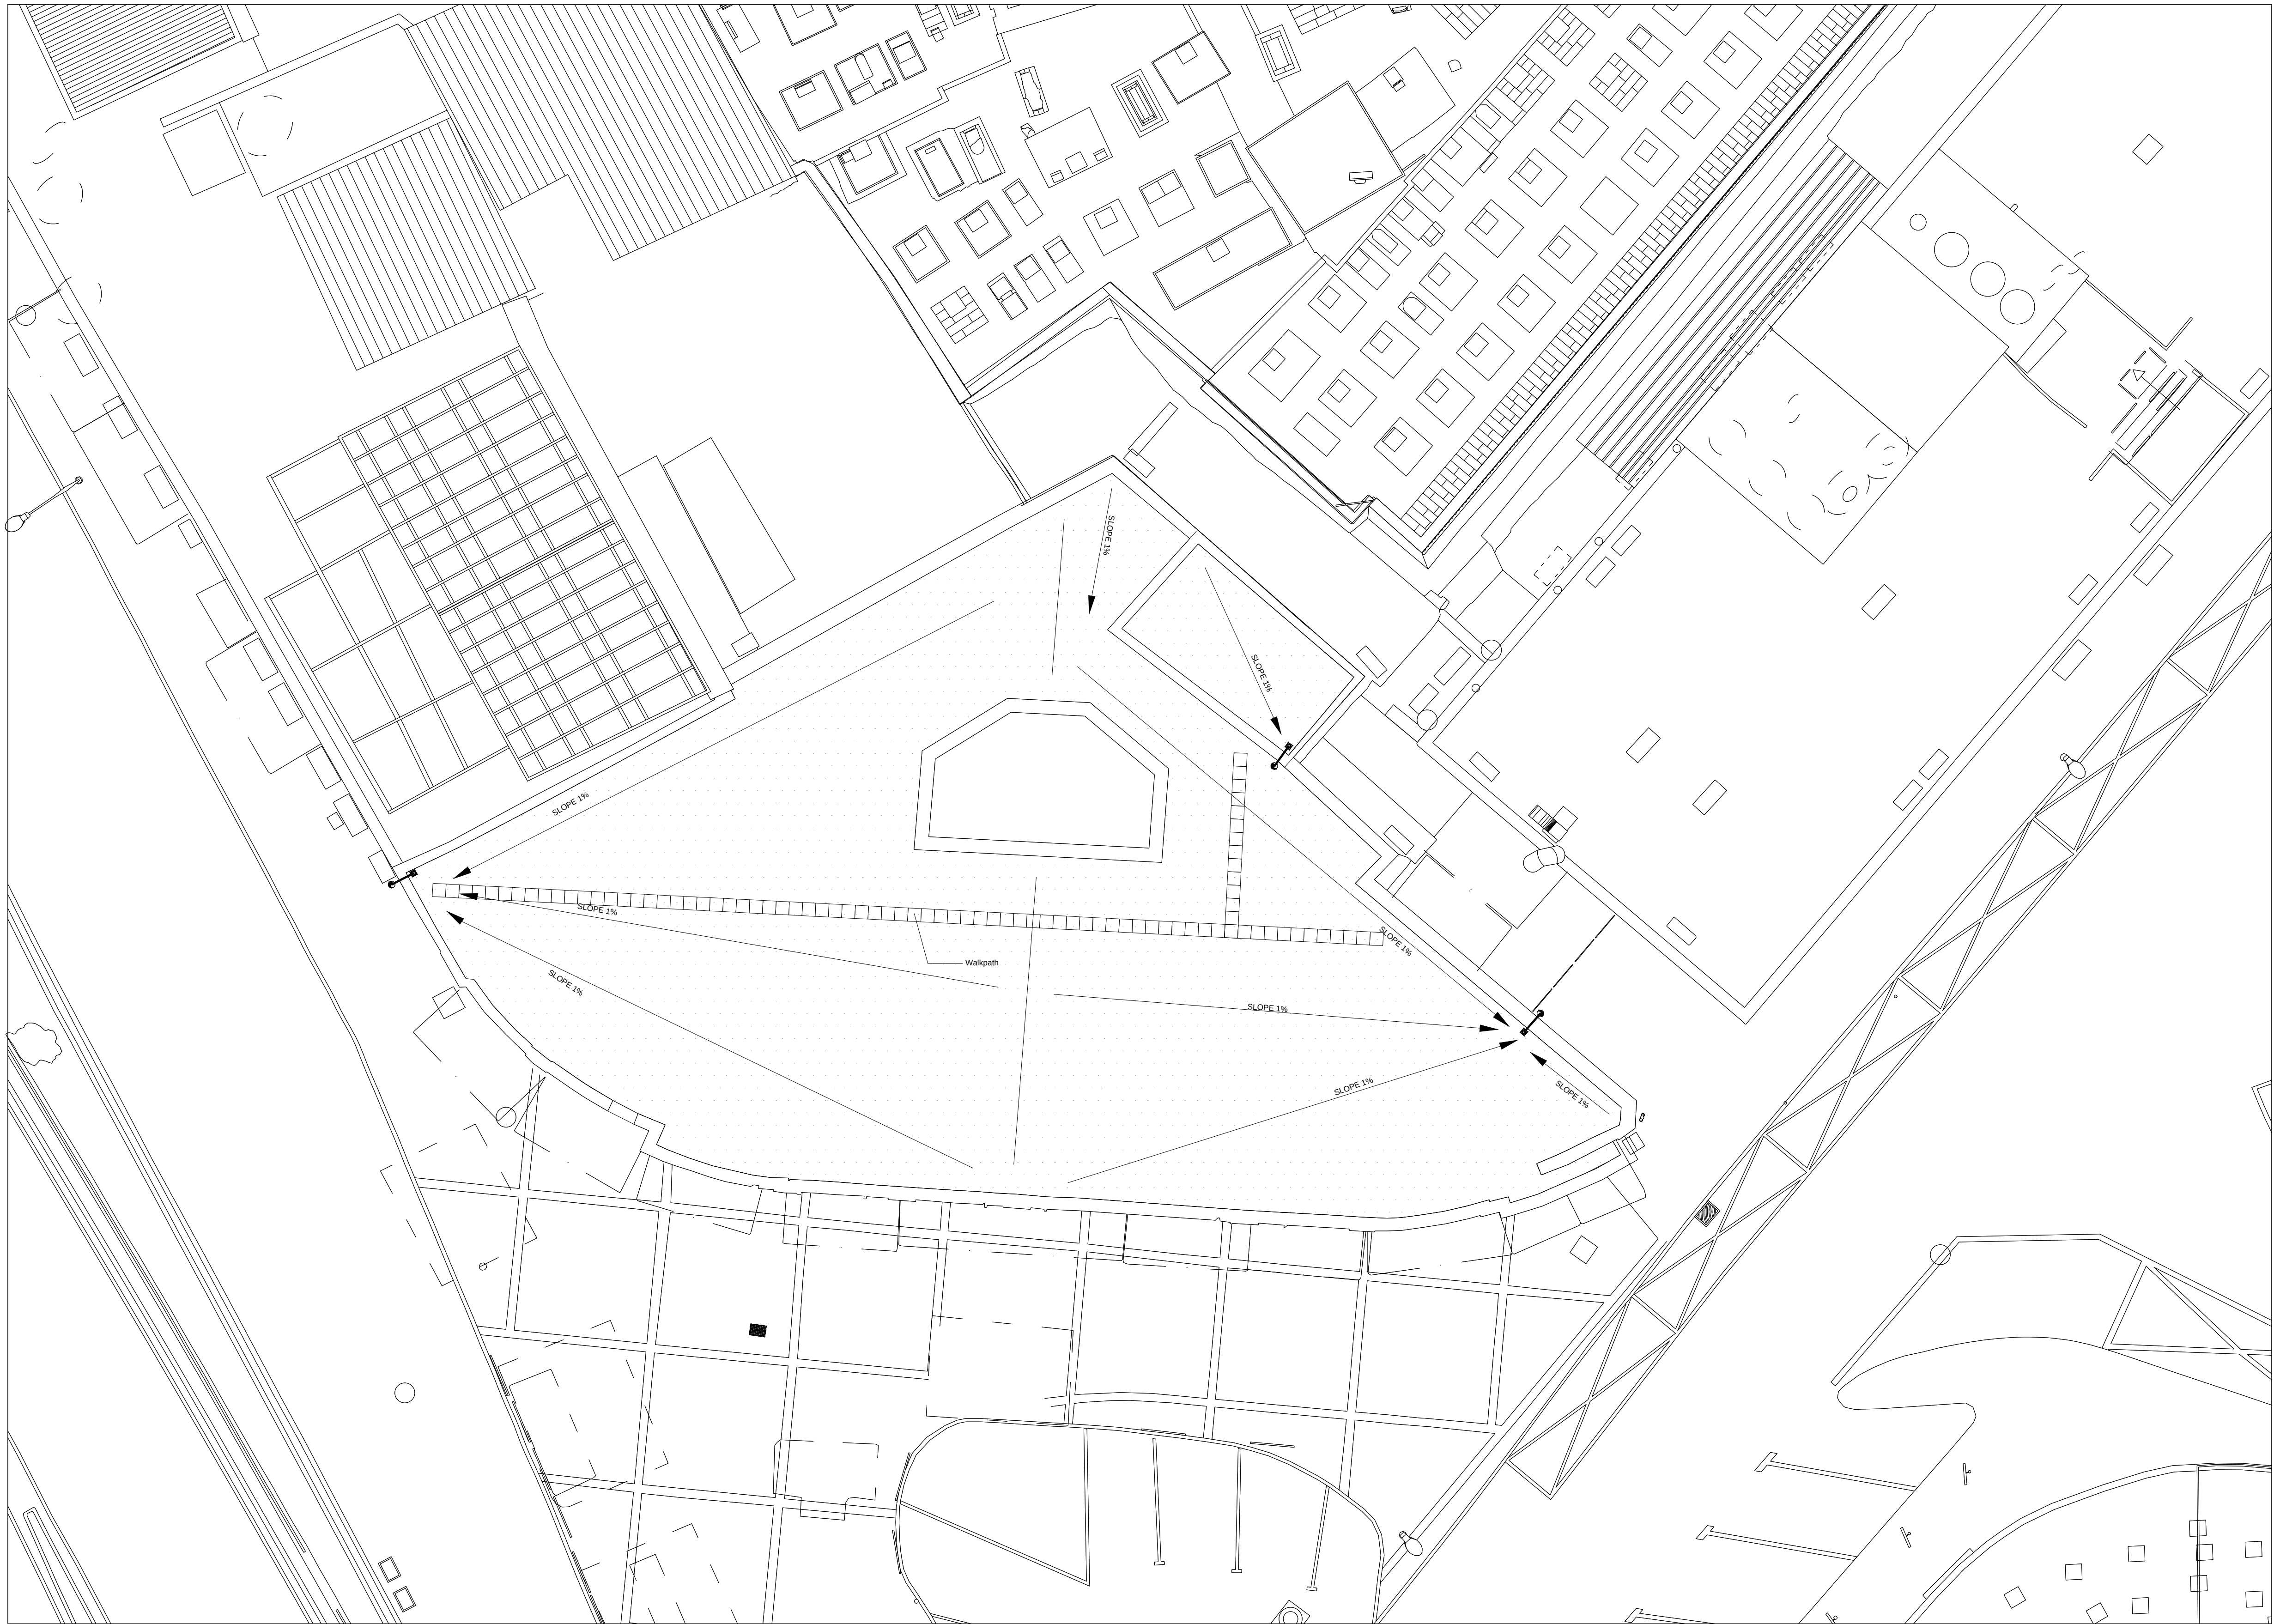

دائرة الأوقاف الإسلامية في القدس

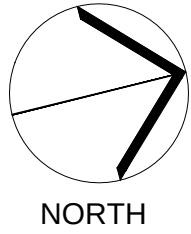

03			
02			
01			
REV.	SUBJECT	DATE	BY

NOTES:
- All Levels in meter
- All dimensions are shown in centimeters.

LEGEND:

- 1- REINFORCED CONCRETE
- 2- CONCRETE
- 3- STONE
- 4- CONCRETE BLOCK
- 5- YTONG BLOCK
- 6- BASE COURSE
- 7- SAND
- 8- COMPACTED FILL OR NATURAL GROUND
- 9- LEVEL SYMBOL (PLAN)
- 10- LEVEL SYMBOL (SECTION - ELEVATION)
- 11- FINISH FLOOR LEVEL
- 12- CONCRETE FLOOR LEVEL
- 13- WINDOW LABEL
- 14- DOOR LABEL
- 15- DETAILS SIGN
- 16- STRUCTURAL SYMBOLS - COLUMNS

1- EXISTING COLUMN
2- RC COLUMN
3- COLUMN CONCRETE JACKETING
4- COLUMN STEEL JACKETING

* REF TO STRUCTURE DRAWINGS TO GET FINAL DATA

PROJECT TITLE
PRODUCTIVITY& URBAN RENEWAL
IN EAST JERUSALEM (PURE)

**RENOVATION WORKS OF
BUILDING SS001**

SHEET TITLE:


Rain Water Drainage

CONSULTANTS:

ZIADAH
ARCHITECTS & ENGINEERS
مهندسون معماريون ومهندسون

DOUR
ENGINEERING & PLANNING
مهندسون معماريون ومهندسون

Scale : 1:100 When Printed At Sheet (A1)	Date : 02/11/2017
Design by : ZIADAH CONSULTANTS	Division : ARCHITECTURAL
checked by : ZIADAH CONSULTANTS	SHEET NO.
Drawn by : ZIADAH CONSULTANTS	A1-05
Project No. 21/16	

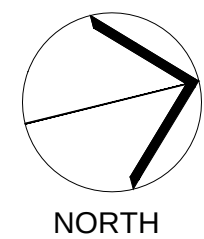

03			
02			
01			
REV.	SUBJECT	DATE	BY

NOTES:
- All Levels in meter
- All dimensions are shown in centimeters.

LEGEND:

1- REINFORCED CONCRETE	
2- CONCRETE	
3- STONE	
4- CONCRETE BLOCK	
5- YTONG BLOCK	
6- BASE COURSE	
7- SAND	
8- COMPACTED FILL OR NATURAL GROUND	
9- LEVEL SYMBOL (PLAN)	
10- LEVEL SYMBOL (SECTION - ELEVATION)	
11- FINISH FLOOR LEVEL	
12- CONCRETE FLOOR LEVEL	
13- WINDOW LABEL	
14- DOOR LABEL	
15- DETAILS SIGN	
16- STRUCTURAL SYMBOLS - COLUMNS	
1- EXISTING COLUMN	
2- RC COLUMN	
3- COLUMN CONCRETE JACKETING	
4- COLUMN STEEL JACKETING	

* REF TO STRUCTURE DRAWINGS TO GET FINAL DATA

PROJECT TITLE
PRODUCTIVITY& URBAN RENEWAL
IN EAST JERUSALEM (PURE)
RENOVATION WORKS OF
BUILDING SS001


SHEET TITLE:
Street Front Elevation (1)

CONSULTANTS:
ZIADAH
ARCHITECTS & ENGINEERS
معماريون ومهندسون
DOUR
ENGINEERING & PLANNING
مهندسون معماريون


Scale : 1:100 When Printed At Sheet (A1)	Date : 02/11/2017
Design by : ZIADAH CONSULTANTS	Division : ARCHITECTURAL
checked by : ZIADAH CONSULTANTS	SHEET NO. A2-01
Drawn by : ZIADAH CONSULTANTS	
Project No. : 21/16	




1 ELEVATION E (1) / EXISTING
1:100

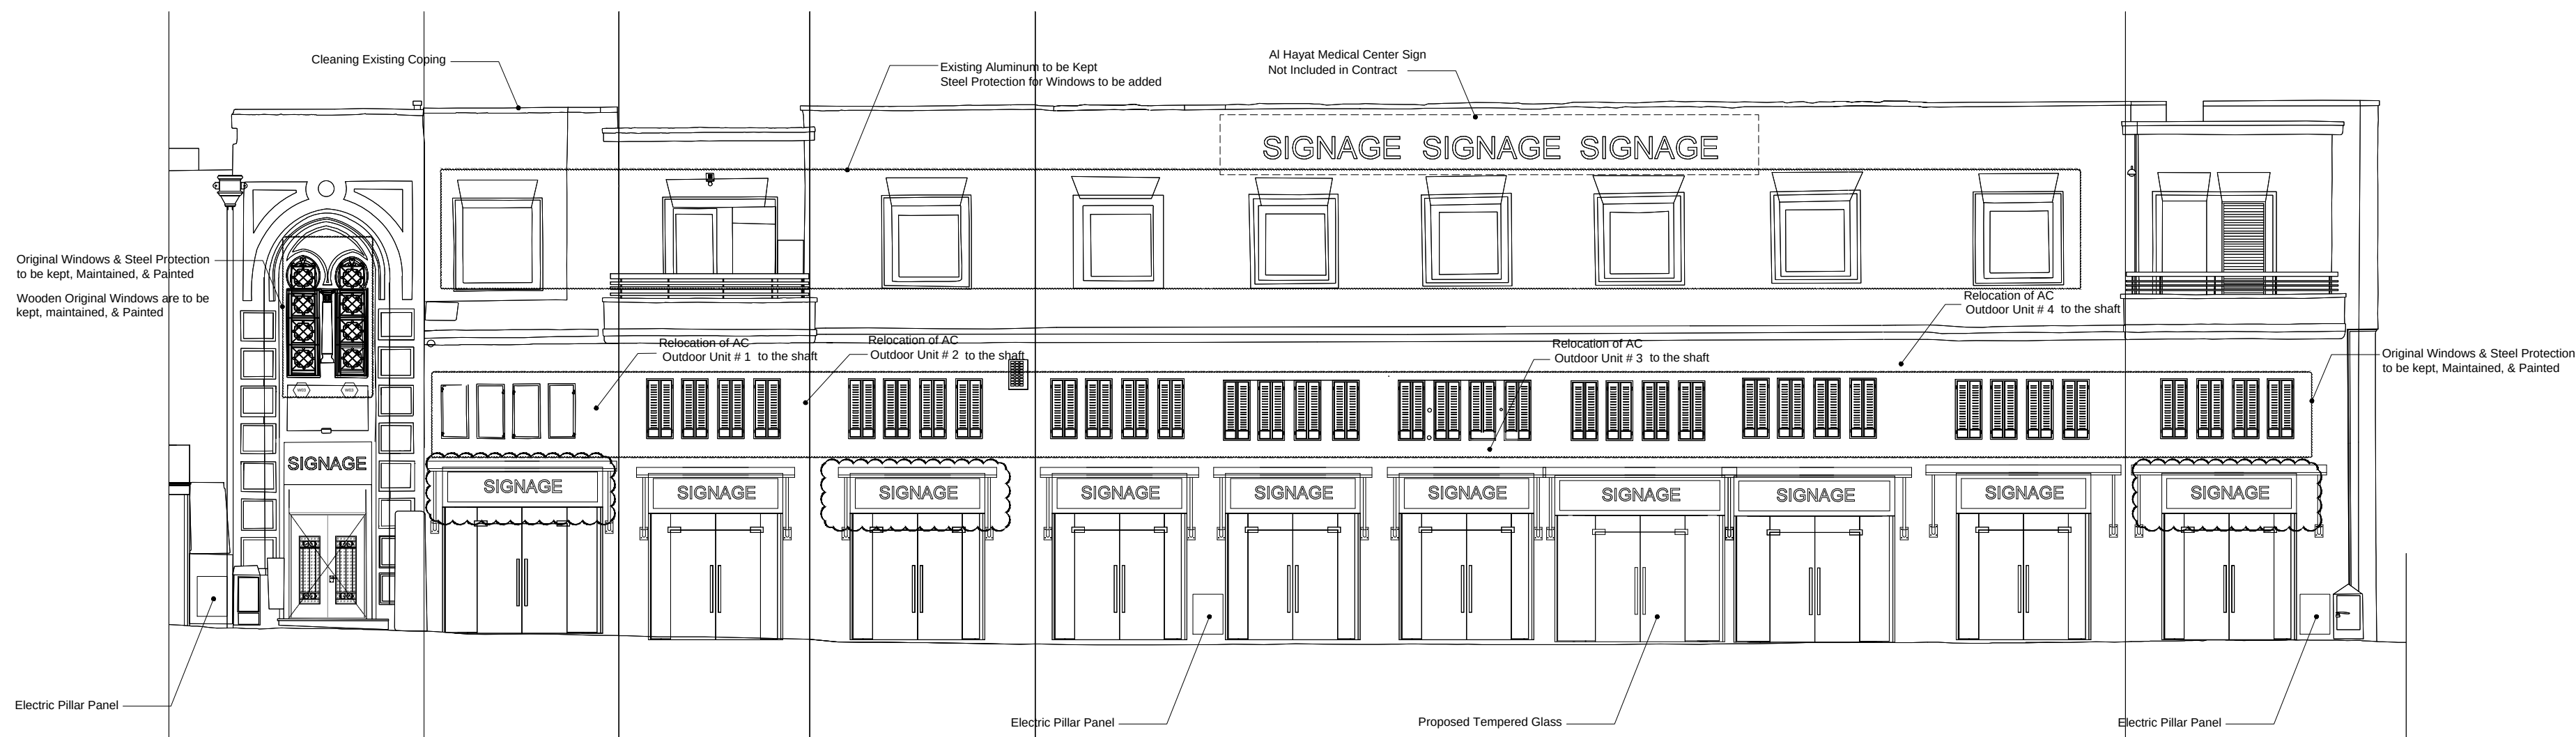

1 ELEVATION E (1) / Interventions
1:100

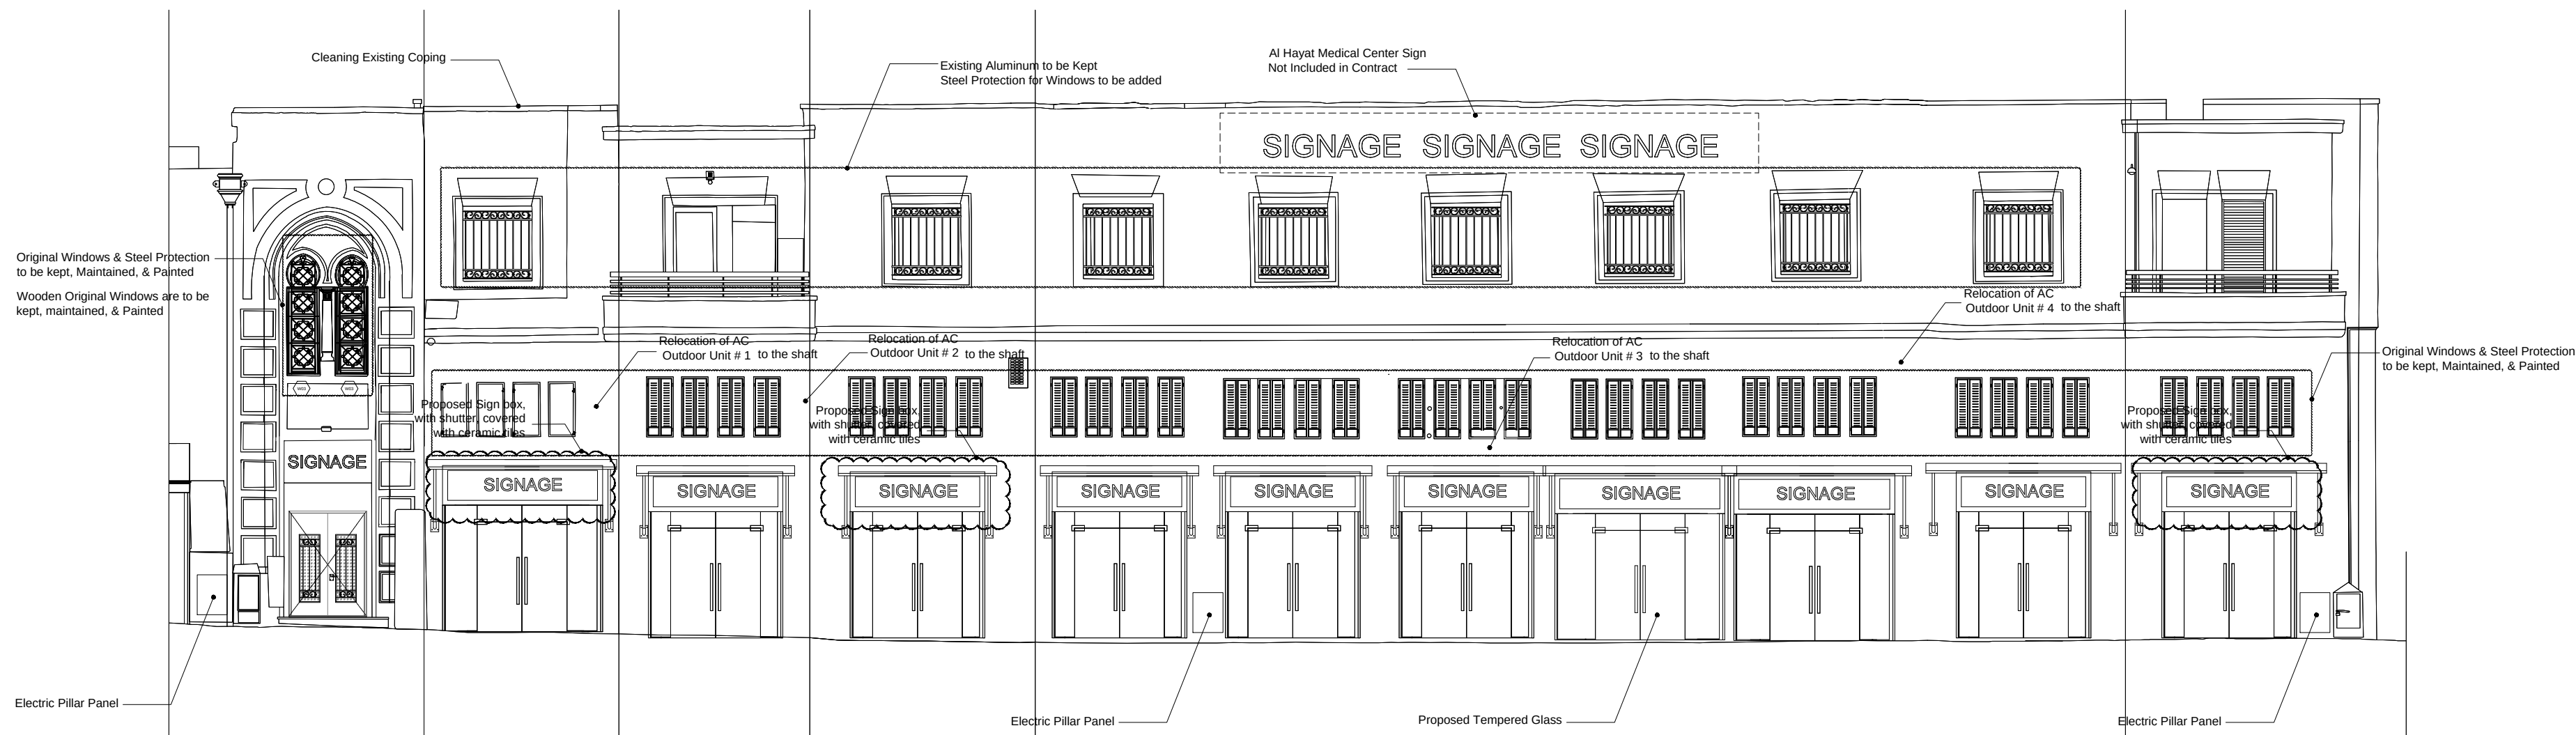


1 ELEVATION E (1) / Proposed
1:100

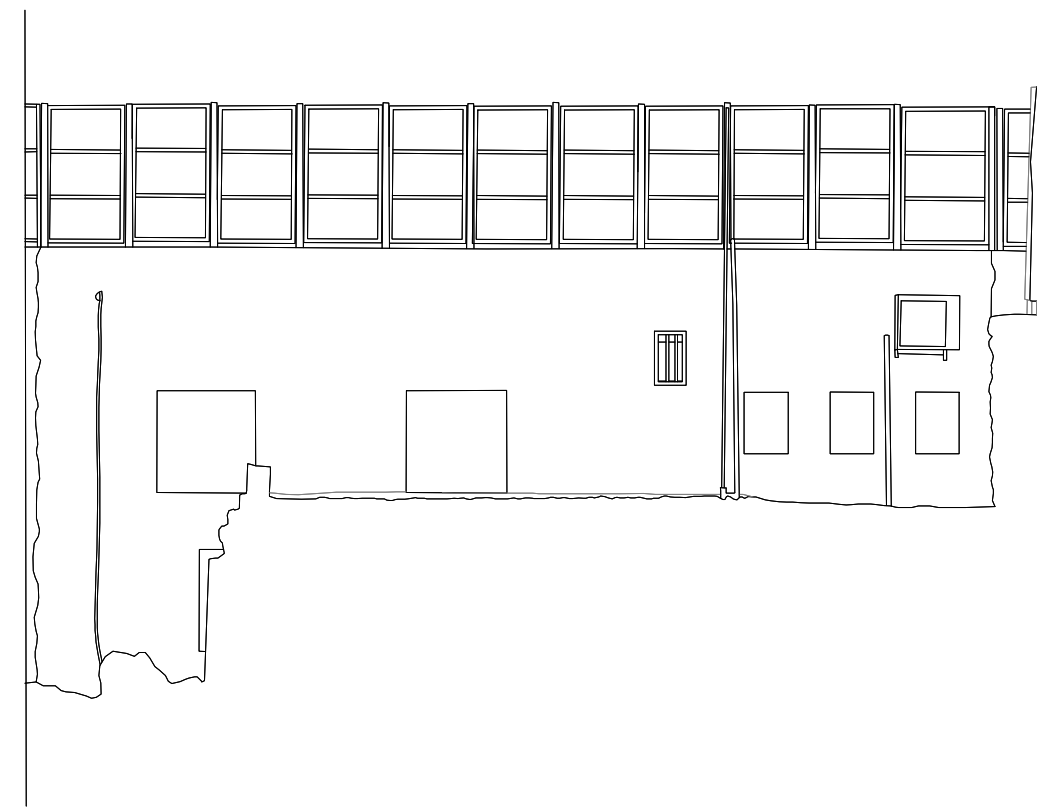


1 SOUTH WEST ELEVATION E (3) / EXISTING
1:100




1 NORTH-WEST ELEVATION E (2) / EXISTING
1:100

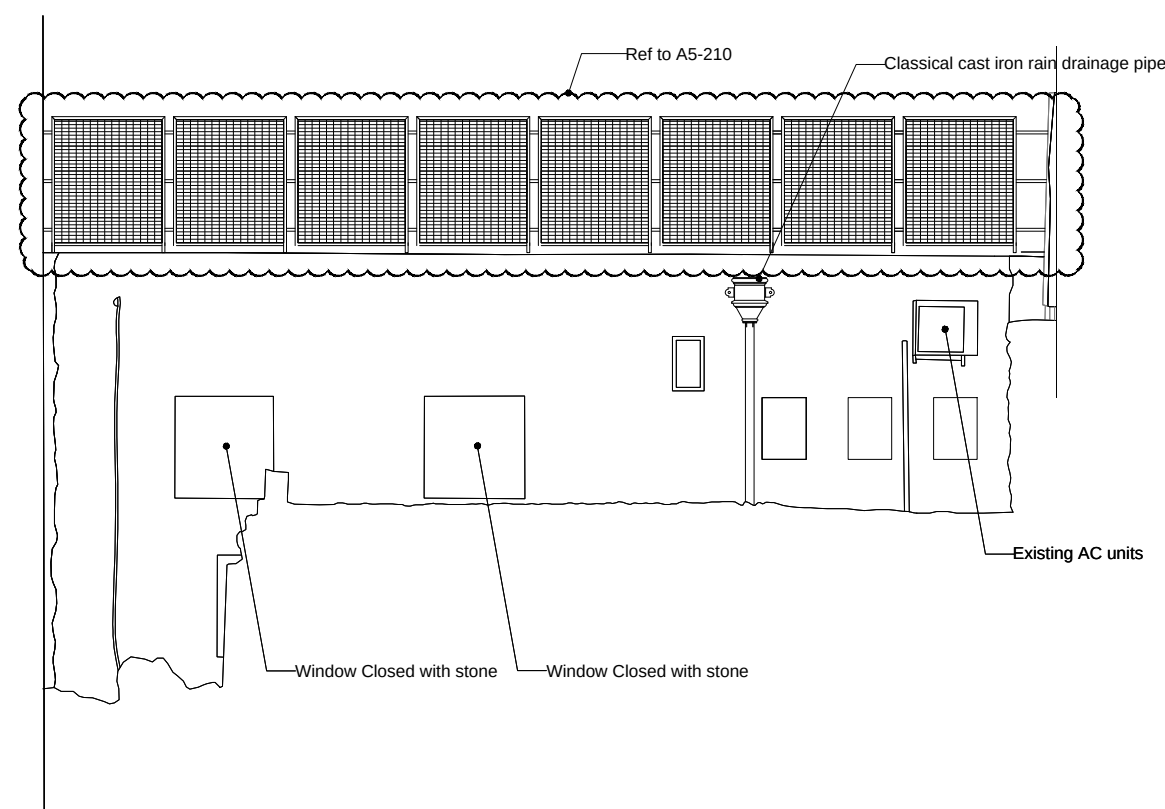


2 SOUTH WEST ELEVATION E (3) / INTERVENTIONS
1:100

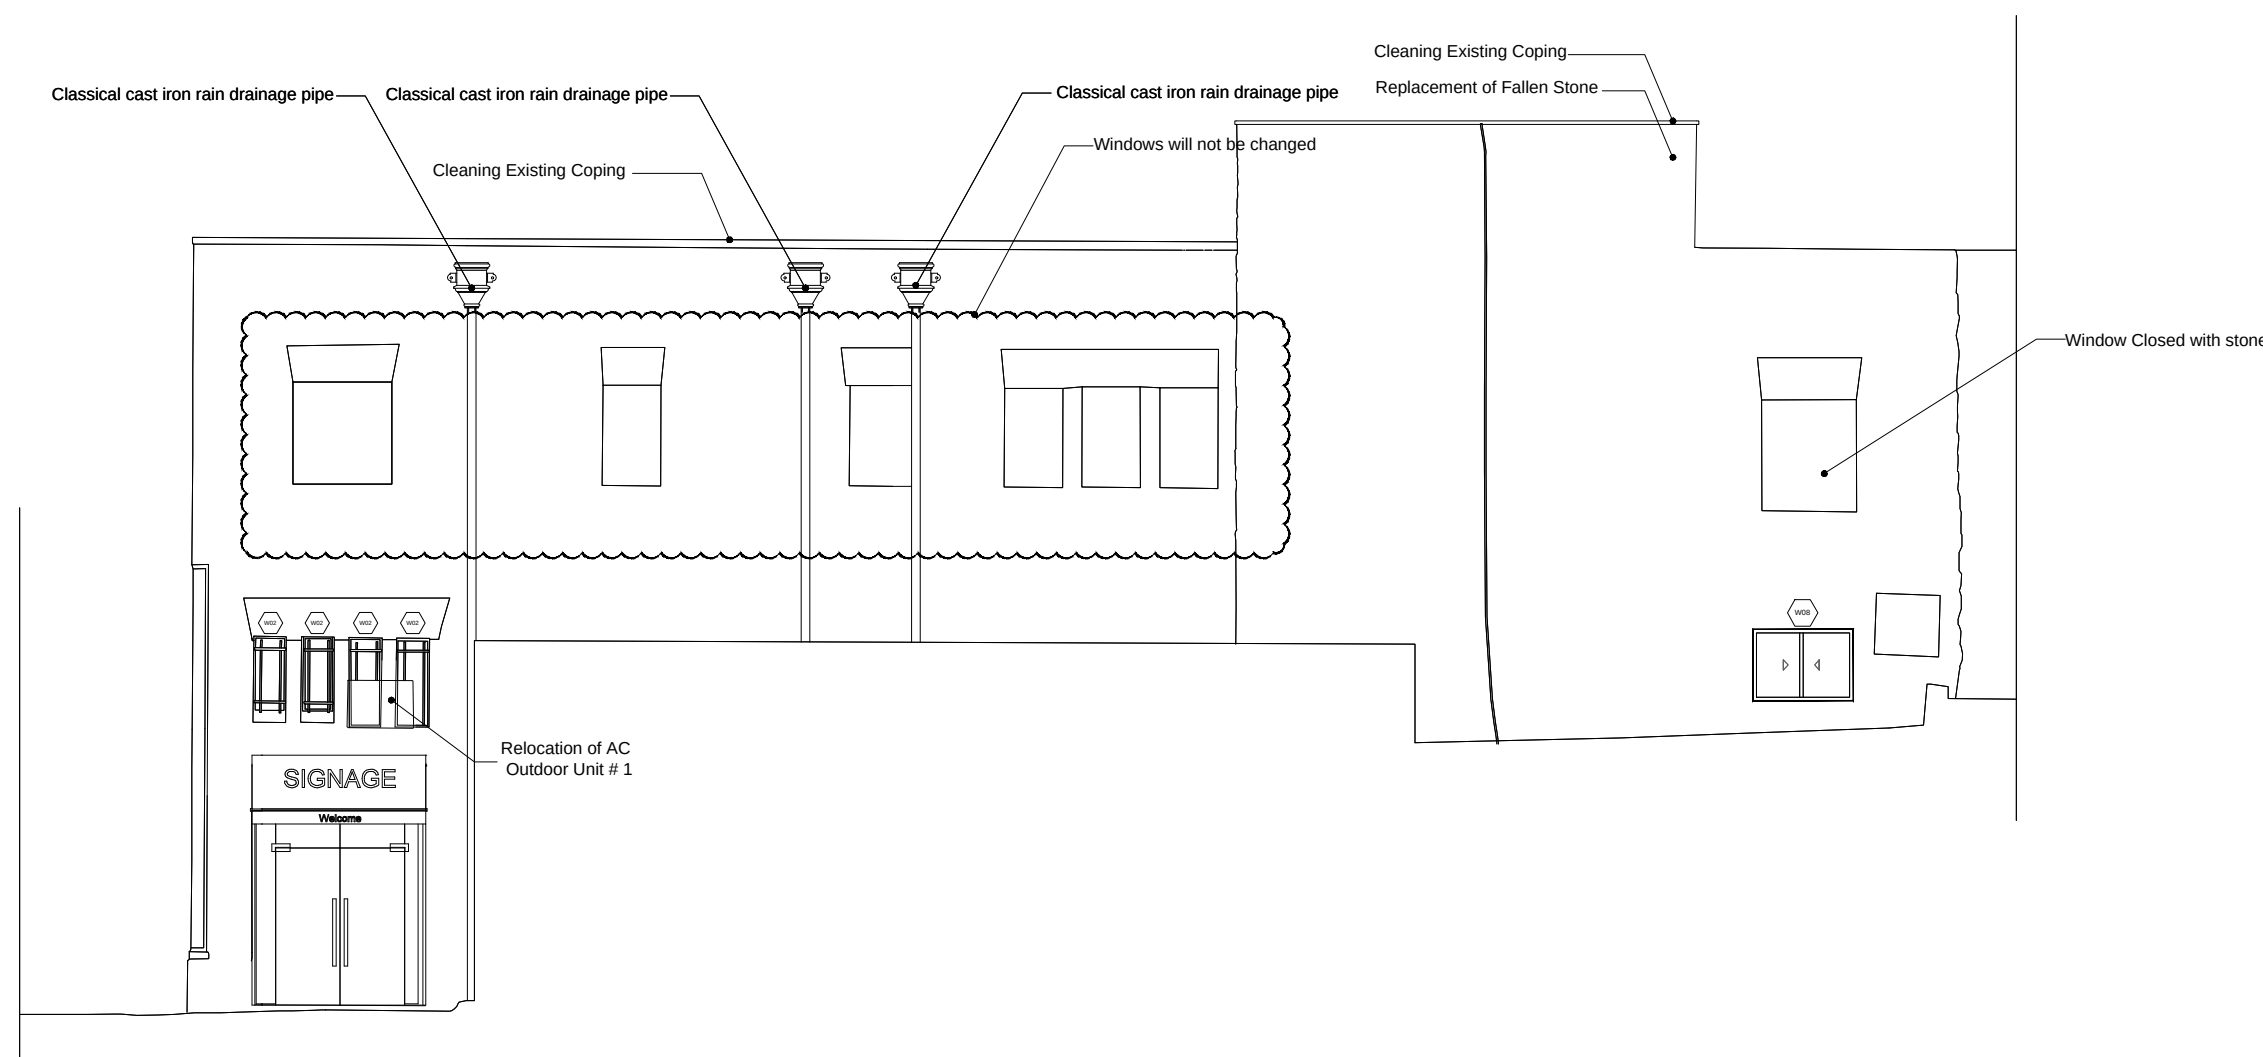

2 NORTH-WEST ELEVATION E (2) / INTERVENTIONS
1:100

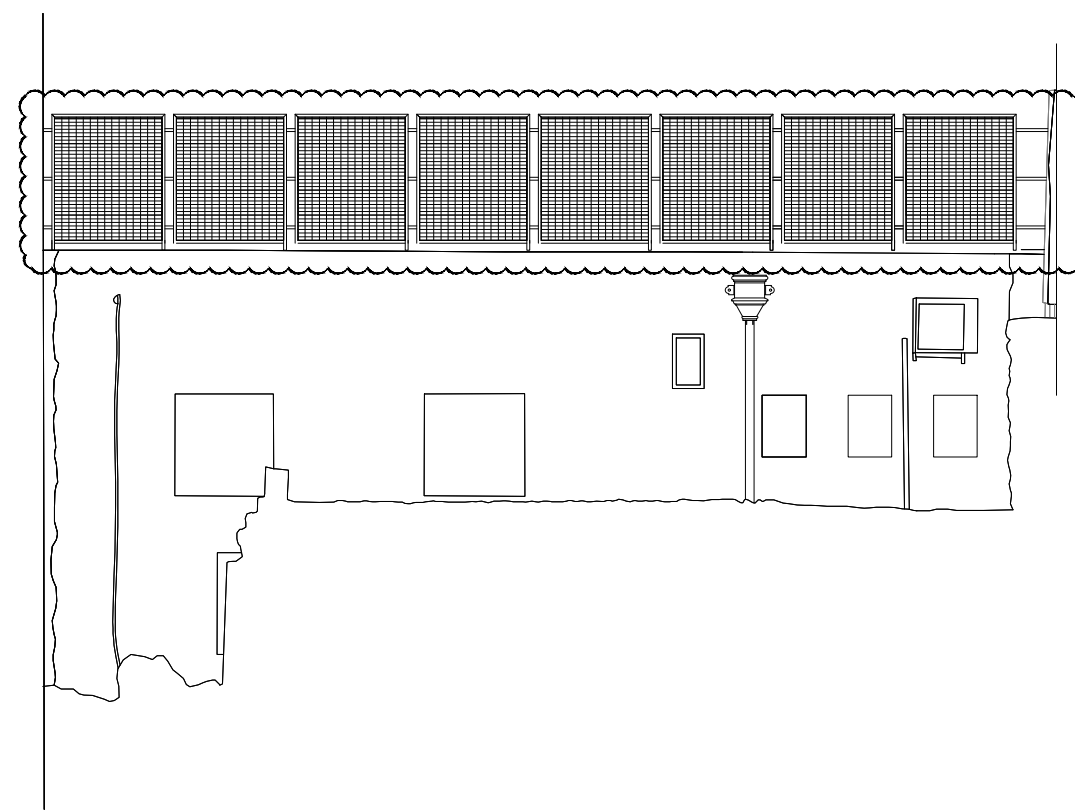

2 SOUTH WEST ELEVATION E (3) / PROPOSED
1:100

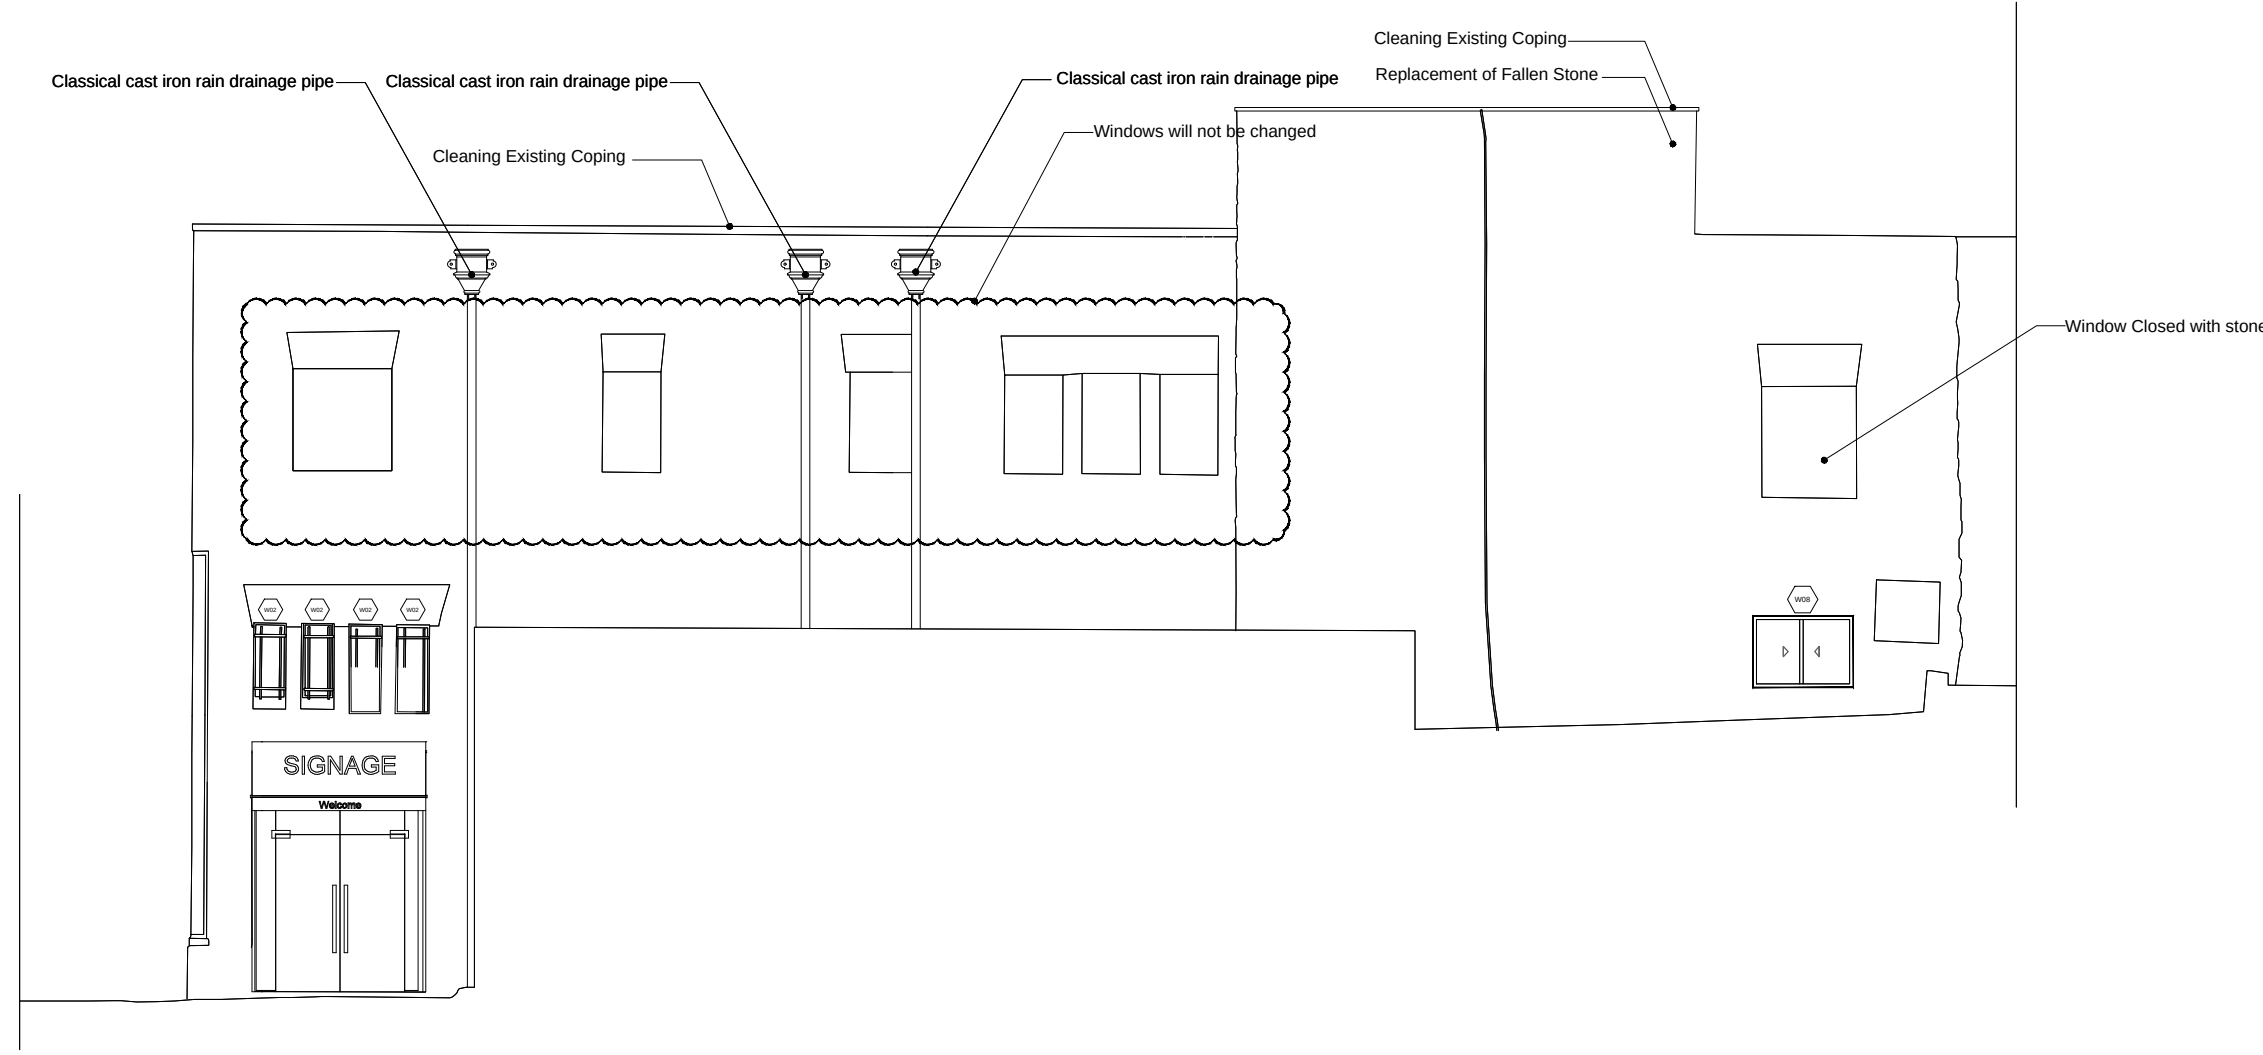

2 NORTH-WEST ELEVATION E (2) / PROPOSED
1:100

دائرة الأوقاف الإسلامية في القدس

هذا المشروع بدعم من

UNDP
United Nations
Development Programme

EUROPEAN UNION

NORTH

03			
02			
01			
REV.	SUBJECT	DATE	BY

NOTES:

- All Levels in meter
- All dimensions are shown in centimeters.

LEGEND:

1- REINFORCED CONCRETE	
2- CONCRETE	
3- STONE	
4- CONCRETE BLOCK	
5- YTONG BLOCK	
6- SAND	
7- COMPACTED FILL OR NATURAL GROUND	
8- LEVEL SYMBOL (PLAN)	
10- LEVEL SYMBOL (SECTION - ELEVATION)	
11- FINISH FLOOR LEVEL	
12- CONCRETE FLOOR LEVEL	
13- WINDOW LABEL	
14- DOOR LABEL	
15- DETAILS SIGN	
16- STRUCTURAL SYMBOLS - COLUMNS	
1- EXISTING COLUMN	
2- RC COLUMN	
3- COLUMN CONCRETE JACKETING	
4- COLUMN STEEL JACKETING	

* REF TO STRUCTURE DRAWINGS TO GET FINAL DATA

PROJECT TITLE

PRODUCTIVITY& URBAN RENEWAL
IN EAST JERUSALEM (PURE)

RENOVATION WORKS OF
BUILDING SS001

SHEET TITLE:

Side Elevations (2&4)

CONSULTANTS:



ZIADAH
ARCHITECTS & ENGINEERS
معماريون ومهندسون

DOUR
ENGINEERING & PLANNING
CONSULTING ENGINEERS


Scale :	Date :
1:100 When Printed At Sheet (A1)	02/11/2017
Design by :	
ZIADAH CONSULTANTS	
checked by :	Division :
ZIADAH CONSULTANTS	ARCHITECTURAL
Drawn by :	SHEET NO.
ZIADAH CONSULTANTS	A2-02
Project No. 21/16	

All Doors Schedule					
WINDOW TYPE	Count (No.)	Width (cm)	Height (cm)	Window Material	Notes
D01	13	180	VAR: 280 - 420	Tempered Glass	Double leaf tempered glass door
D07	1	100	210	Metal Door	Single leaf Metal Strong door
D08	1	160	234	Metal Door	Double Metal Door for Entrances
D09	1	160	234	Metal Door	Double Metal Door for Exit
All dimensions are approximated, Exact dimensions shall be taken on site					

All Windows Schedule					
WINDOW TYPE	Count (No.)	Height (cm)	Width (cm)	Window Material	Notes
W02	4	120	55	Aluminium	Hinged window with fixed panel
W04	3	85	60	Aluminium	Sliding Window without Shutters
W10	3	104	100	Aluminium	Sliding Window without Shutters
W11	2	104	155	Aluminium	Sliding Window without Shutters
W12	4	104	140	Aluminium	Sliding Window without Shutters
All dimensions are approximated, Exact dimensions shall be taken on site					

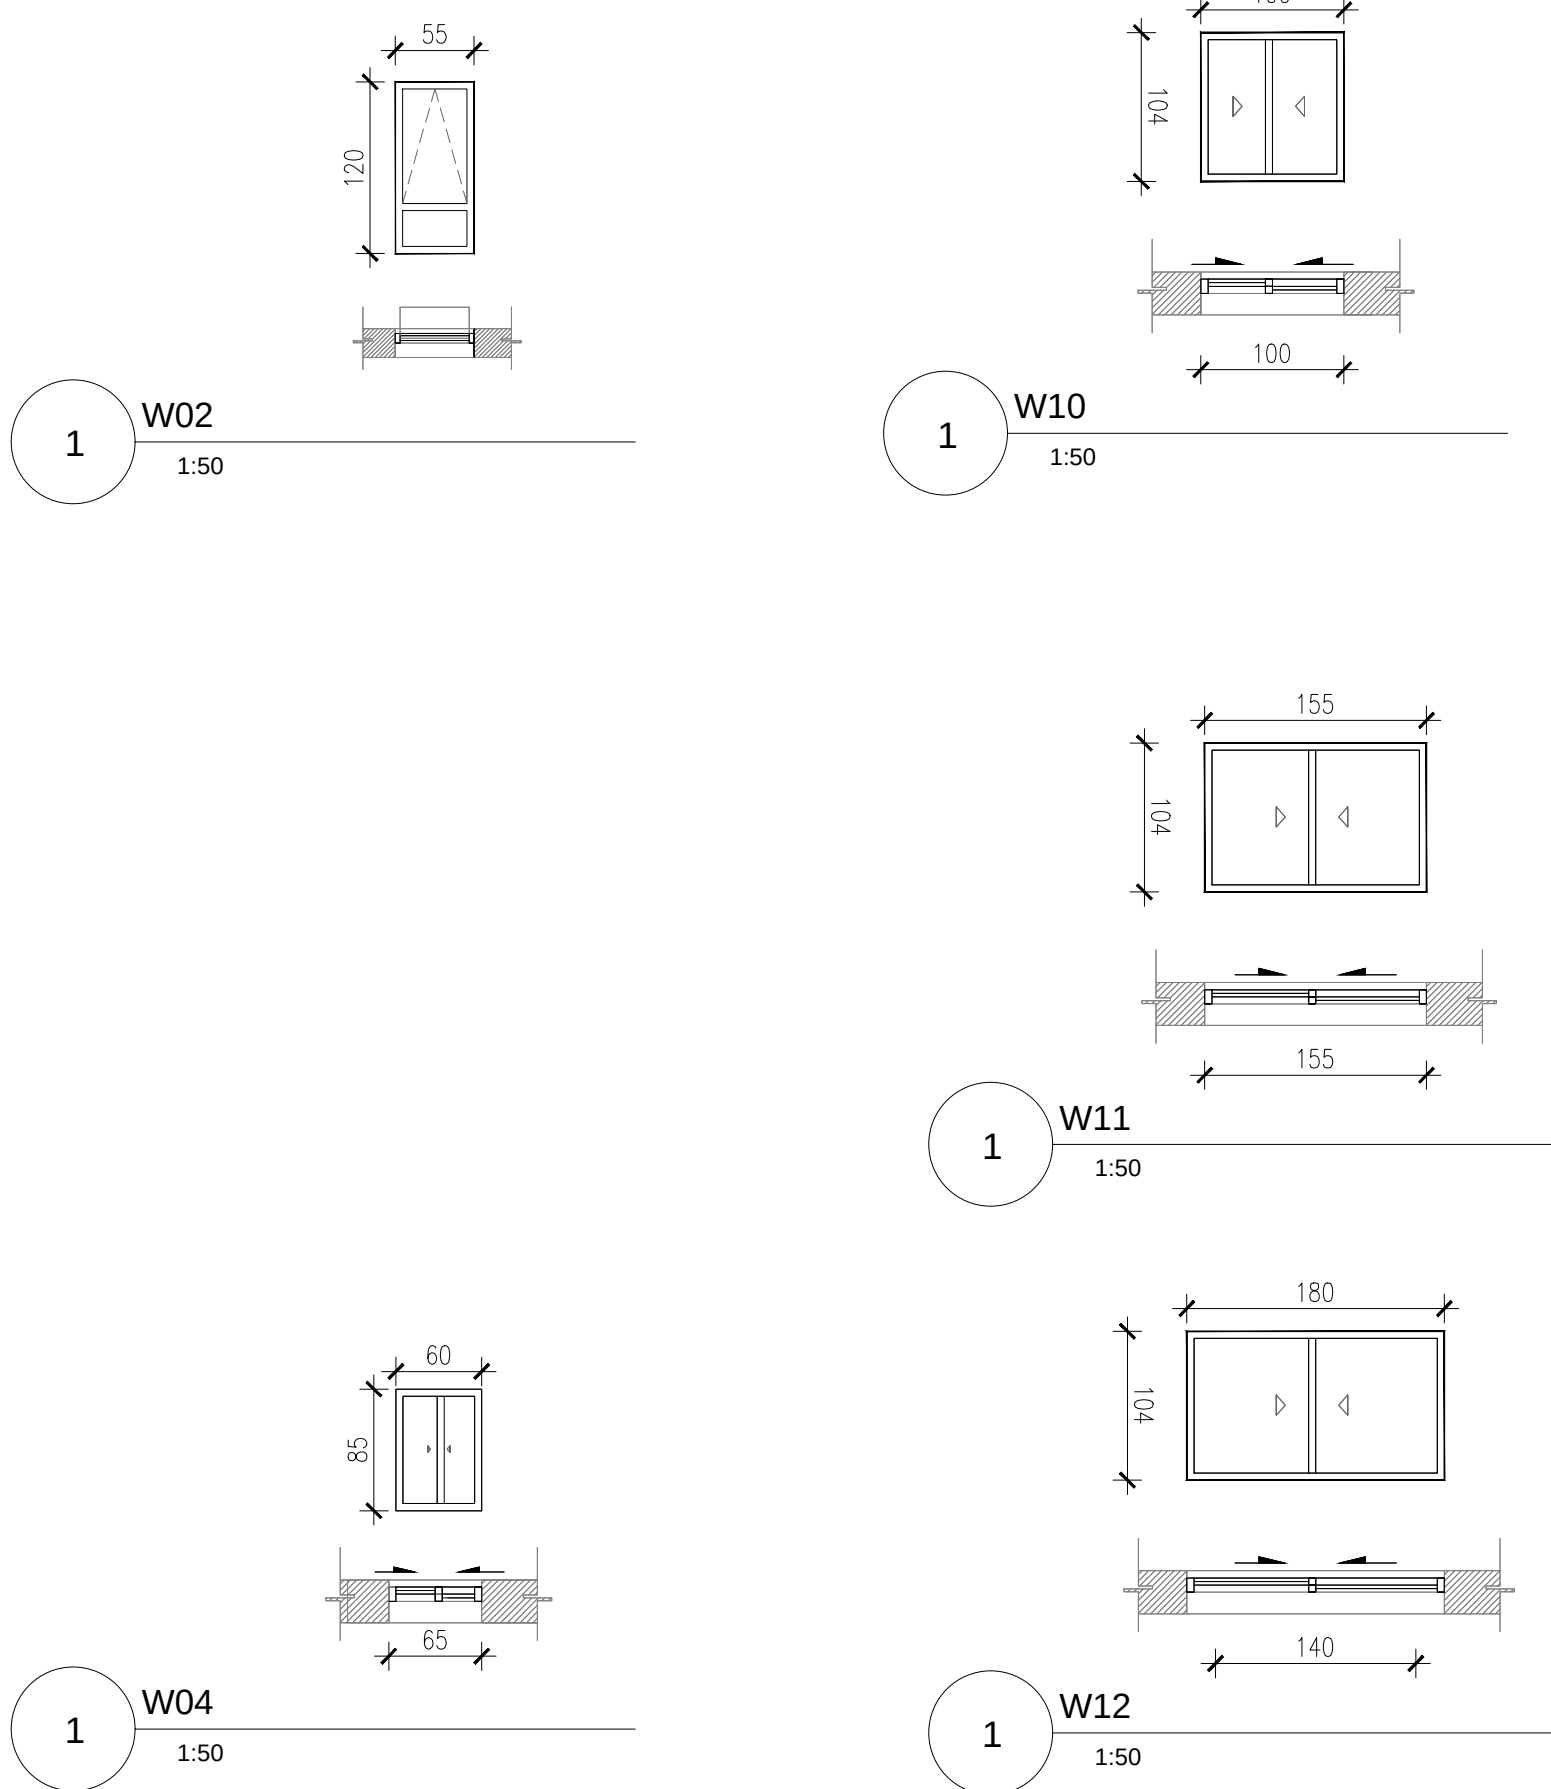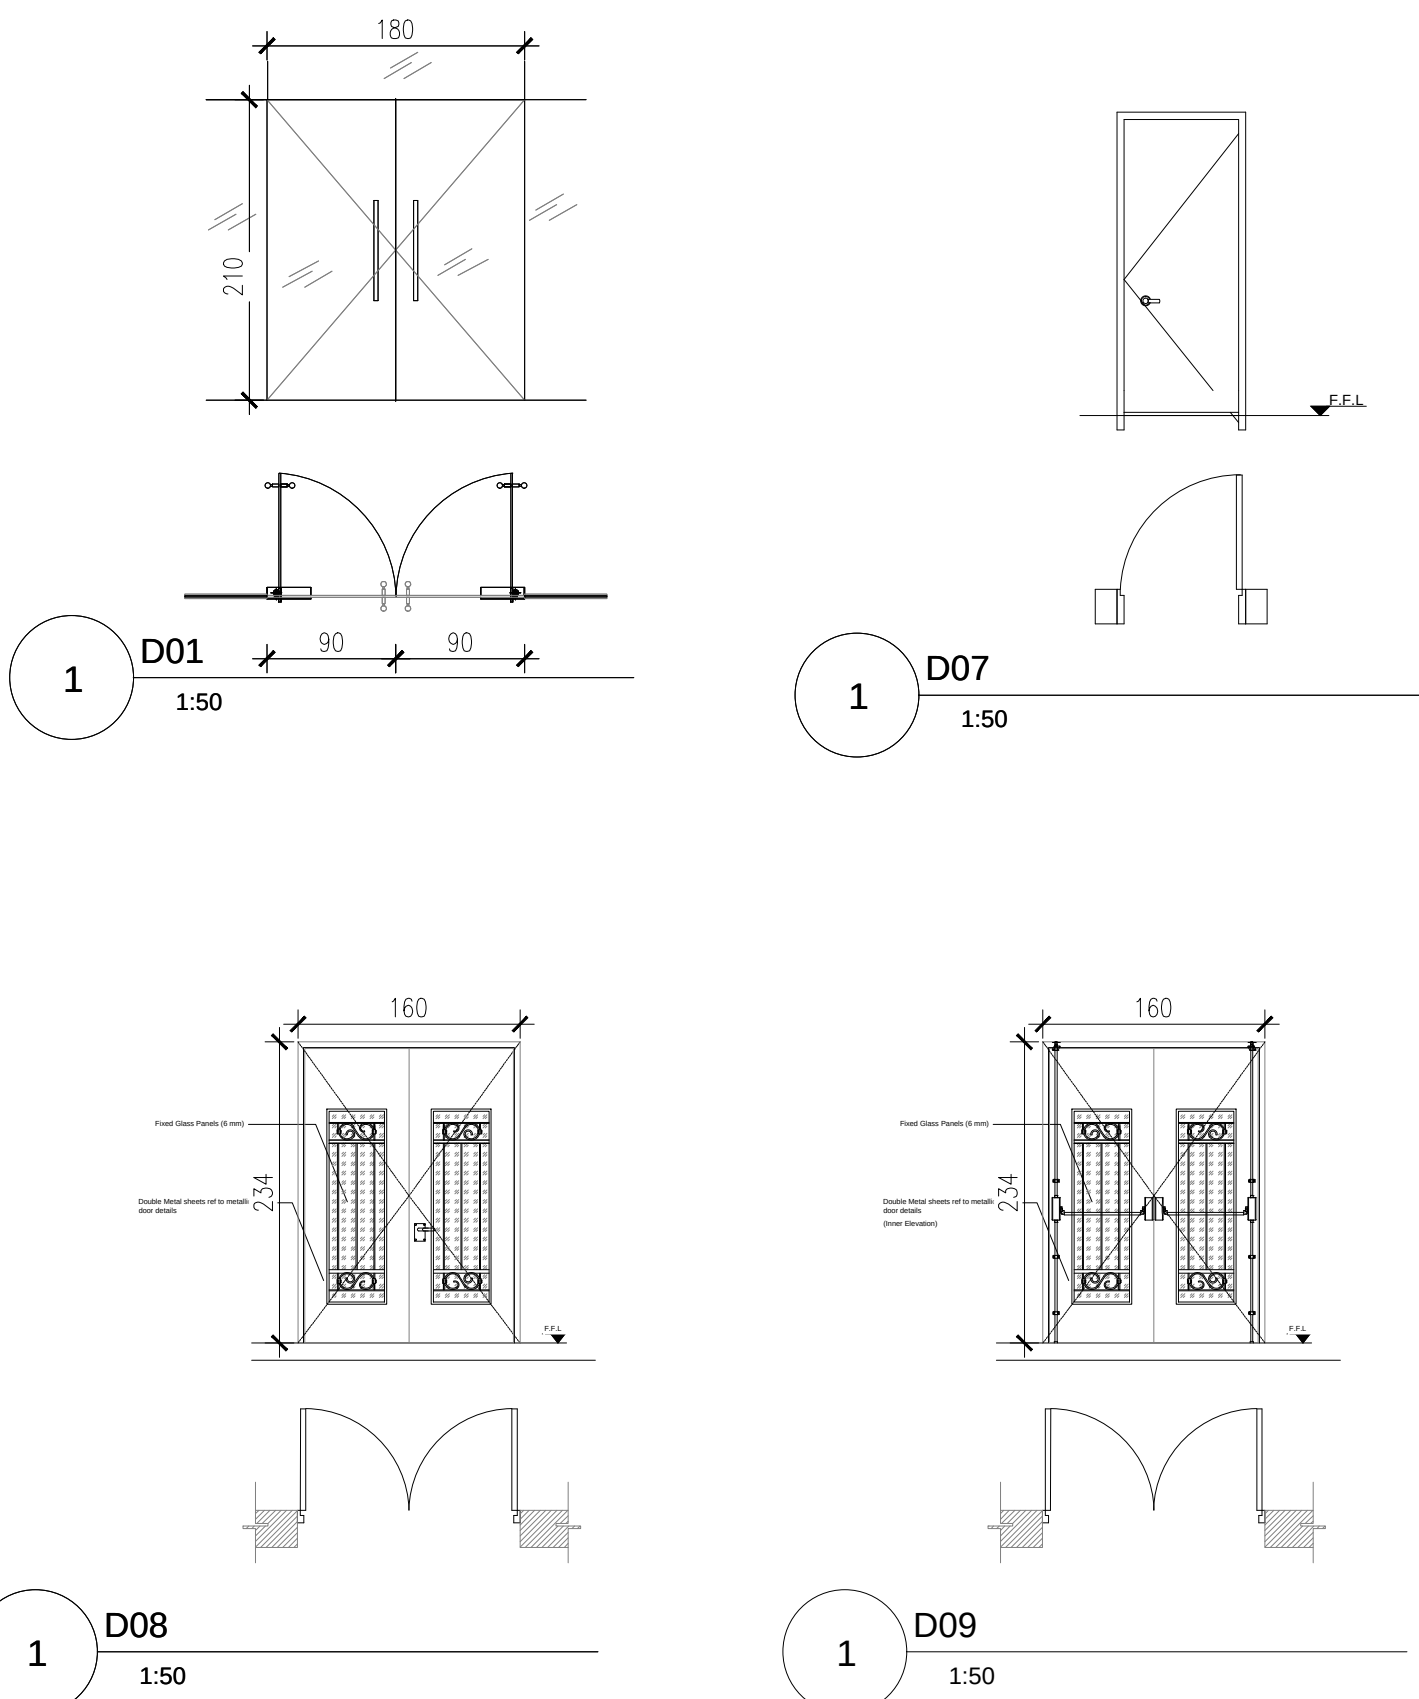

دائرة الأوقاف الإسلامية في القدس

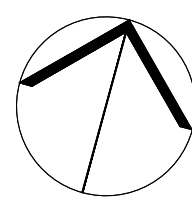

03			
02			
01			
REV.	SUBJECT	DATE	BY

NOTES:
- All Levels in meter
- All dimensions are shown in centimeters.




- LEGEND:
- 1- REINFORCED CONCRETE
 - 2- CONCRETE
 - 3- STONE
 - 4- CONCRETE BLOCK
 - 5- YTONG BLOCK
 - 5- BASE COURSE
 - 6- SAND
 - 7- COMPACTED FILL OR NATURAL GROUND
 - 8- LEVEL SYMBOL (PLAN)
 - 10- LEVEL SYMBOL (SECTION - ELEVATION)
 - 11- FINISH FLOOR LEVEL
 - 12- CONCRETE FLOOR LEVEL
 - 13- WINDOW LABEL
 - 14- DOOR LABEL
 - 15- DETAILS SIGN
 - 16- STRUCTURAL SYMBOLS - COLUMNS
- * REF TO STRUCTURE DRAWINGS TO GET FINAL DATA

PROJECT TITLE
PRODUCTIVITY& URBAN RENEWAL
IN EAST JERUSALEM (PURE)
RENOVATION WORKS OF
BUILDING SD007

SHEET TITLE:
Doors & Windows

CONSULTANTS:
ZIADAH
ARCHITECTS & ENGINEERS
معماريون ومهندسون
DOUR
ENGINEERING & PLANNING
CONSULTING ENGINEERS


Scale : 1:100 When Printed At Sheet (A1)	Date : 05/08/2017
Design by : ZIADAH CONSULTANTS	Division : ARCHITECTURAL
checked by: ZIADAH CONSULTANTS	SHEET NO. A6-01
Drawn by: ZIADAH CONSULTANTS	Project No. 21/16

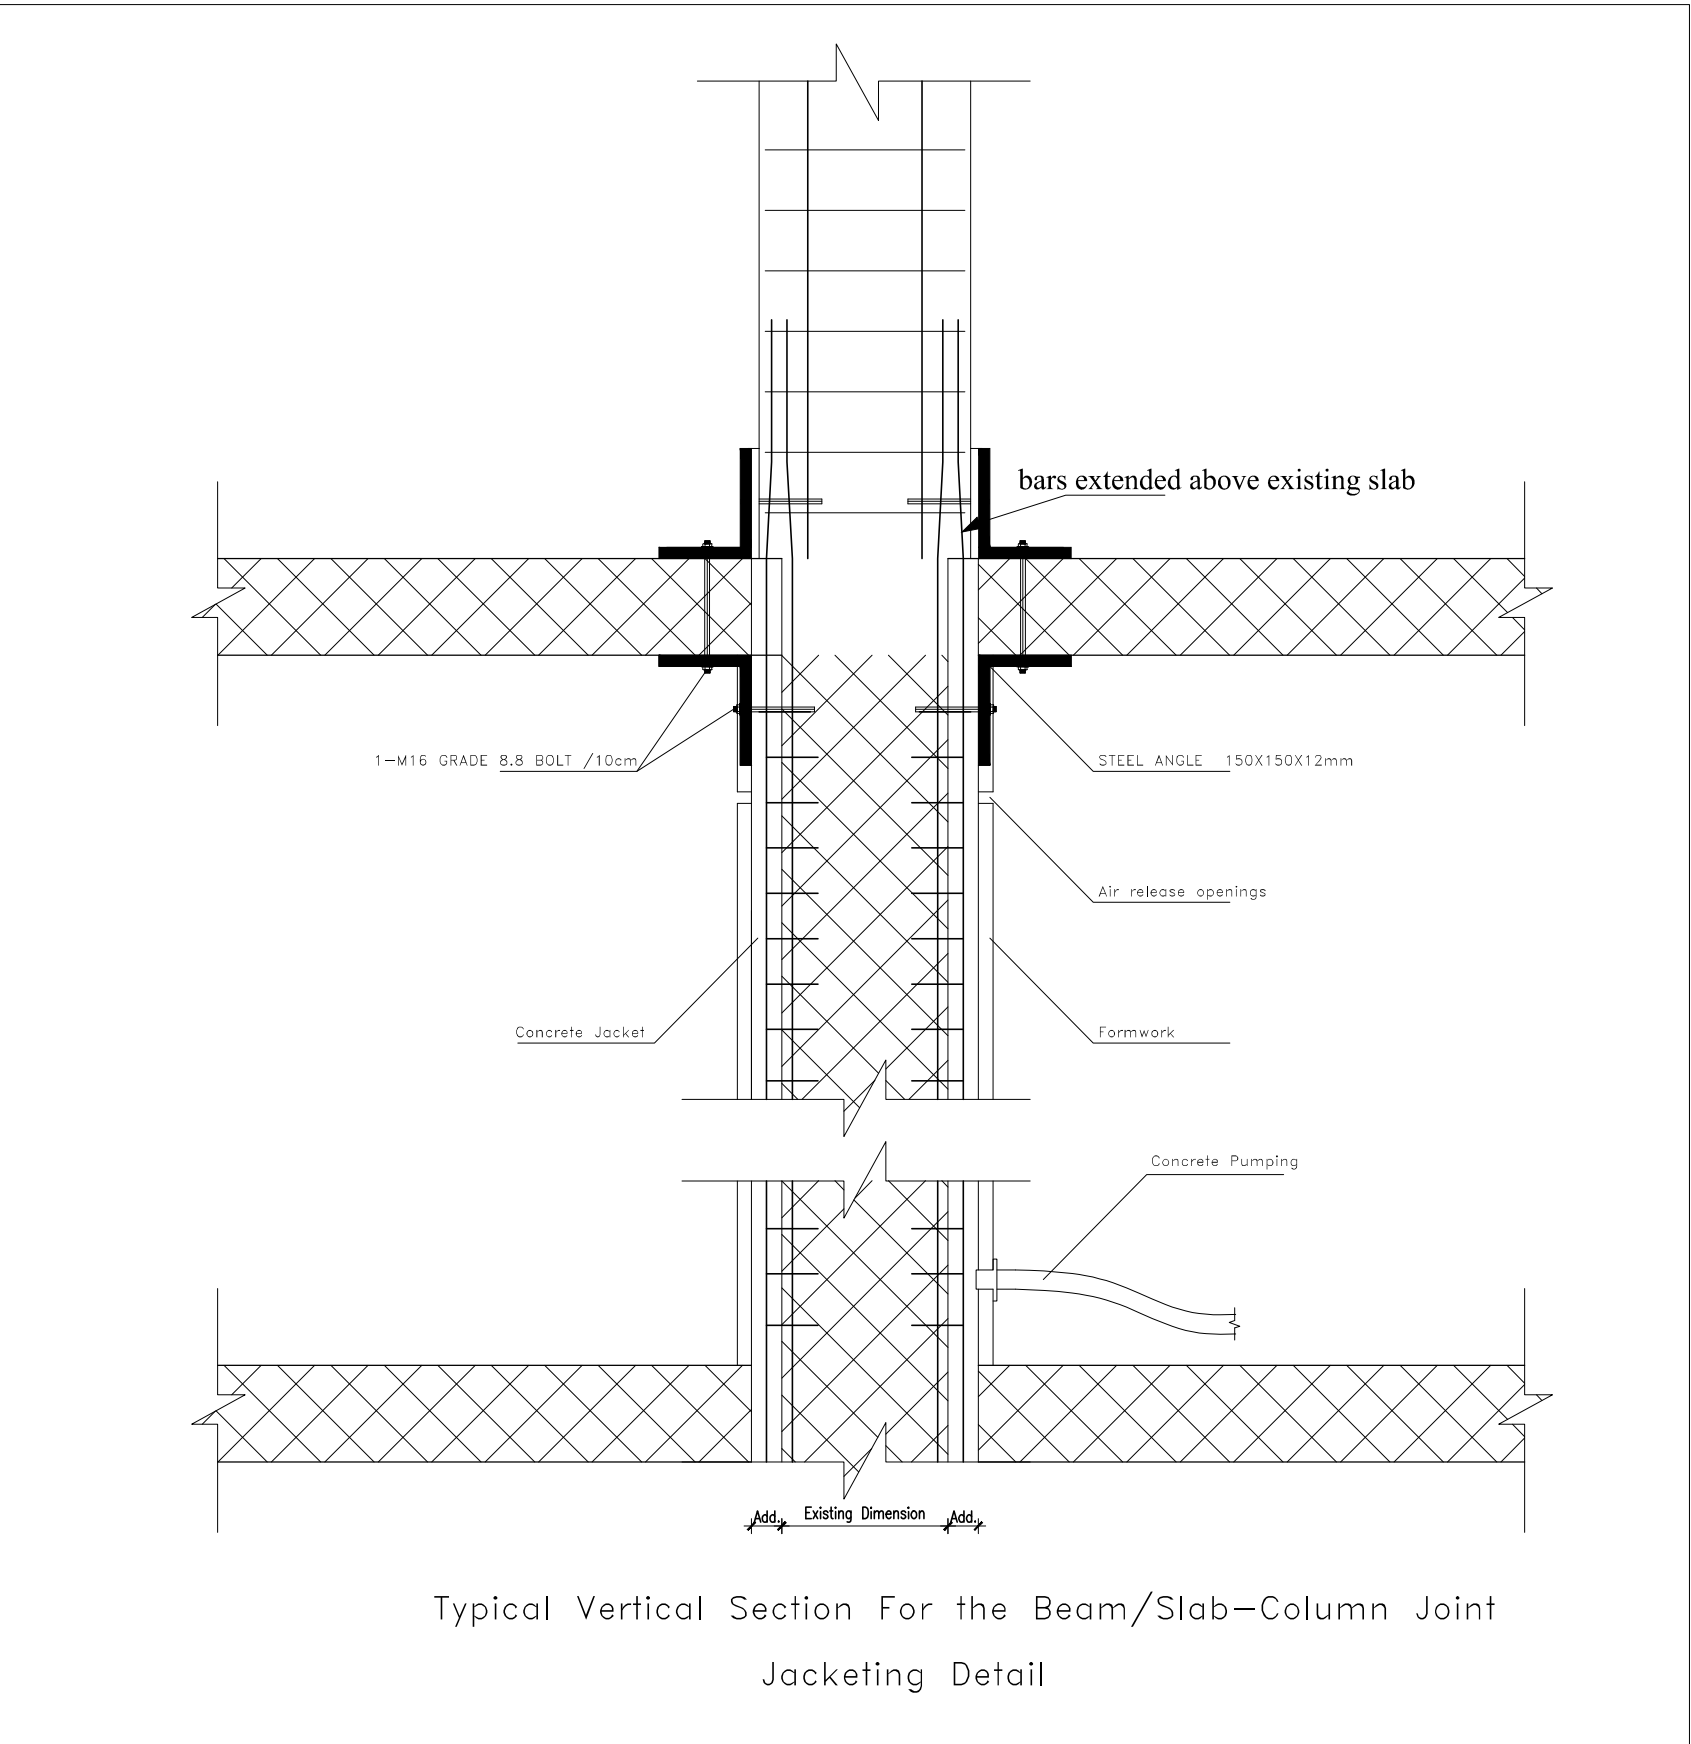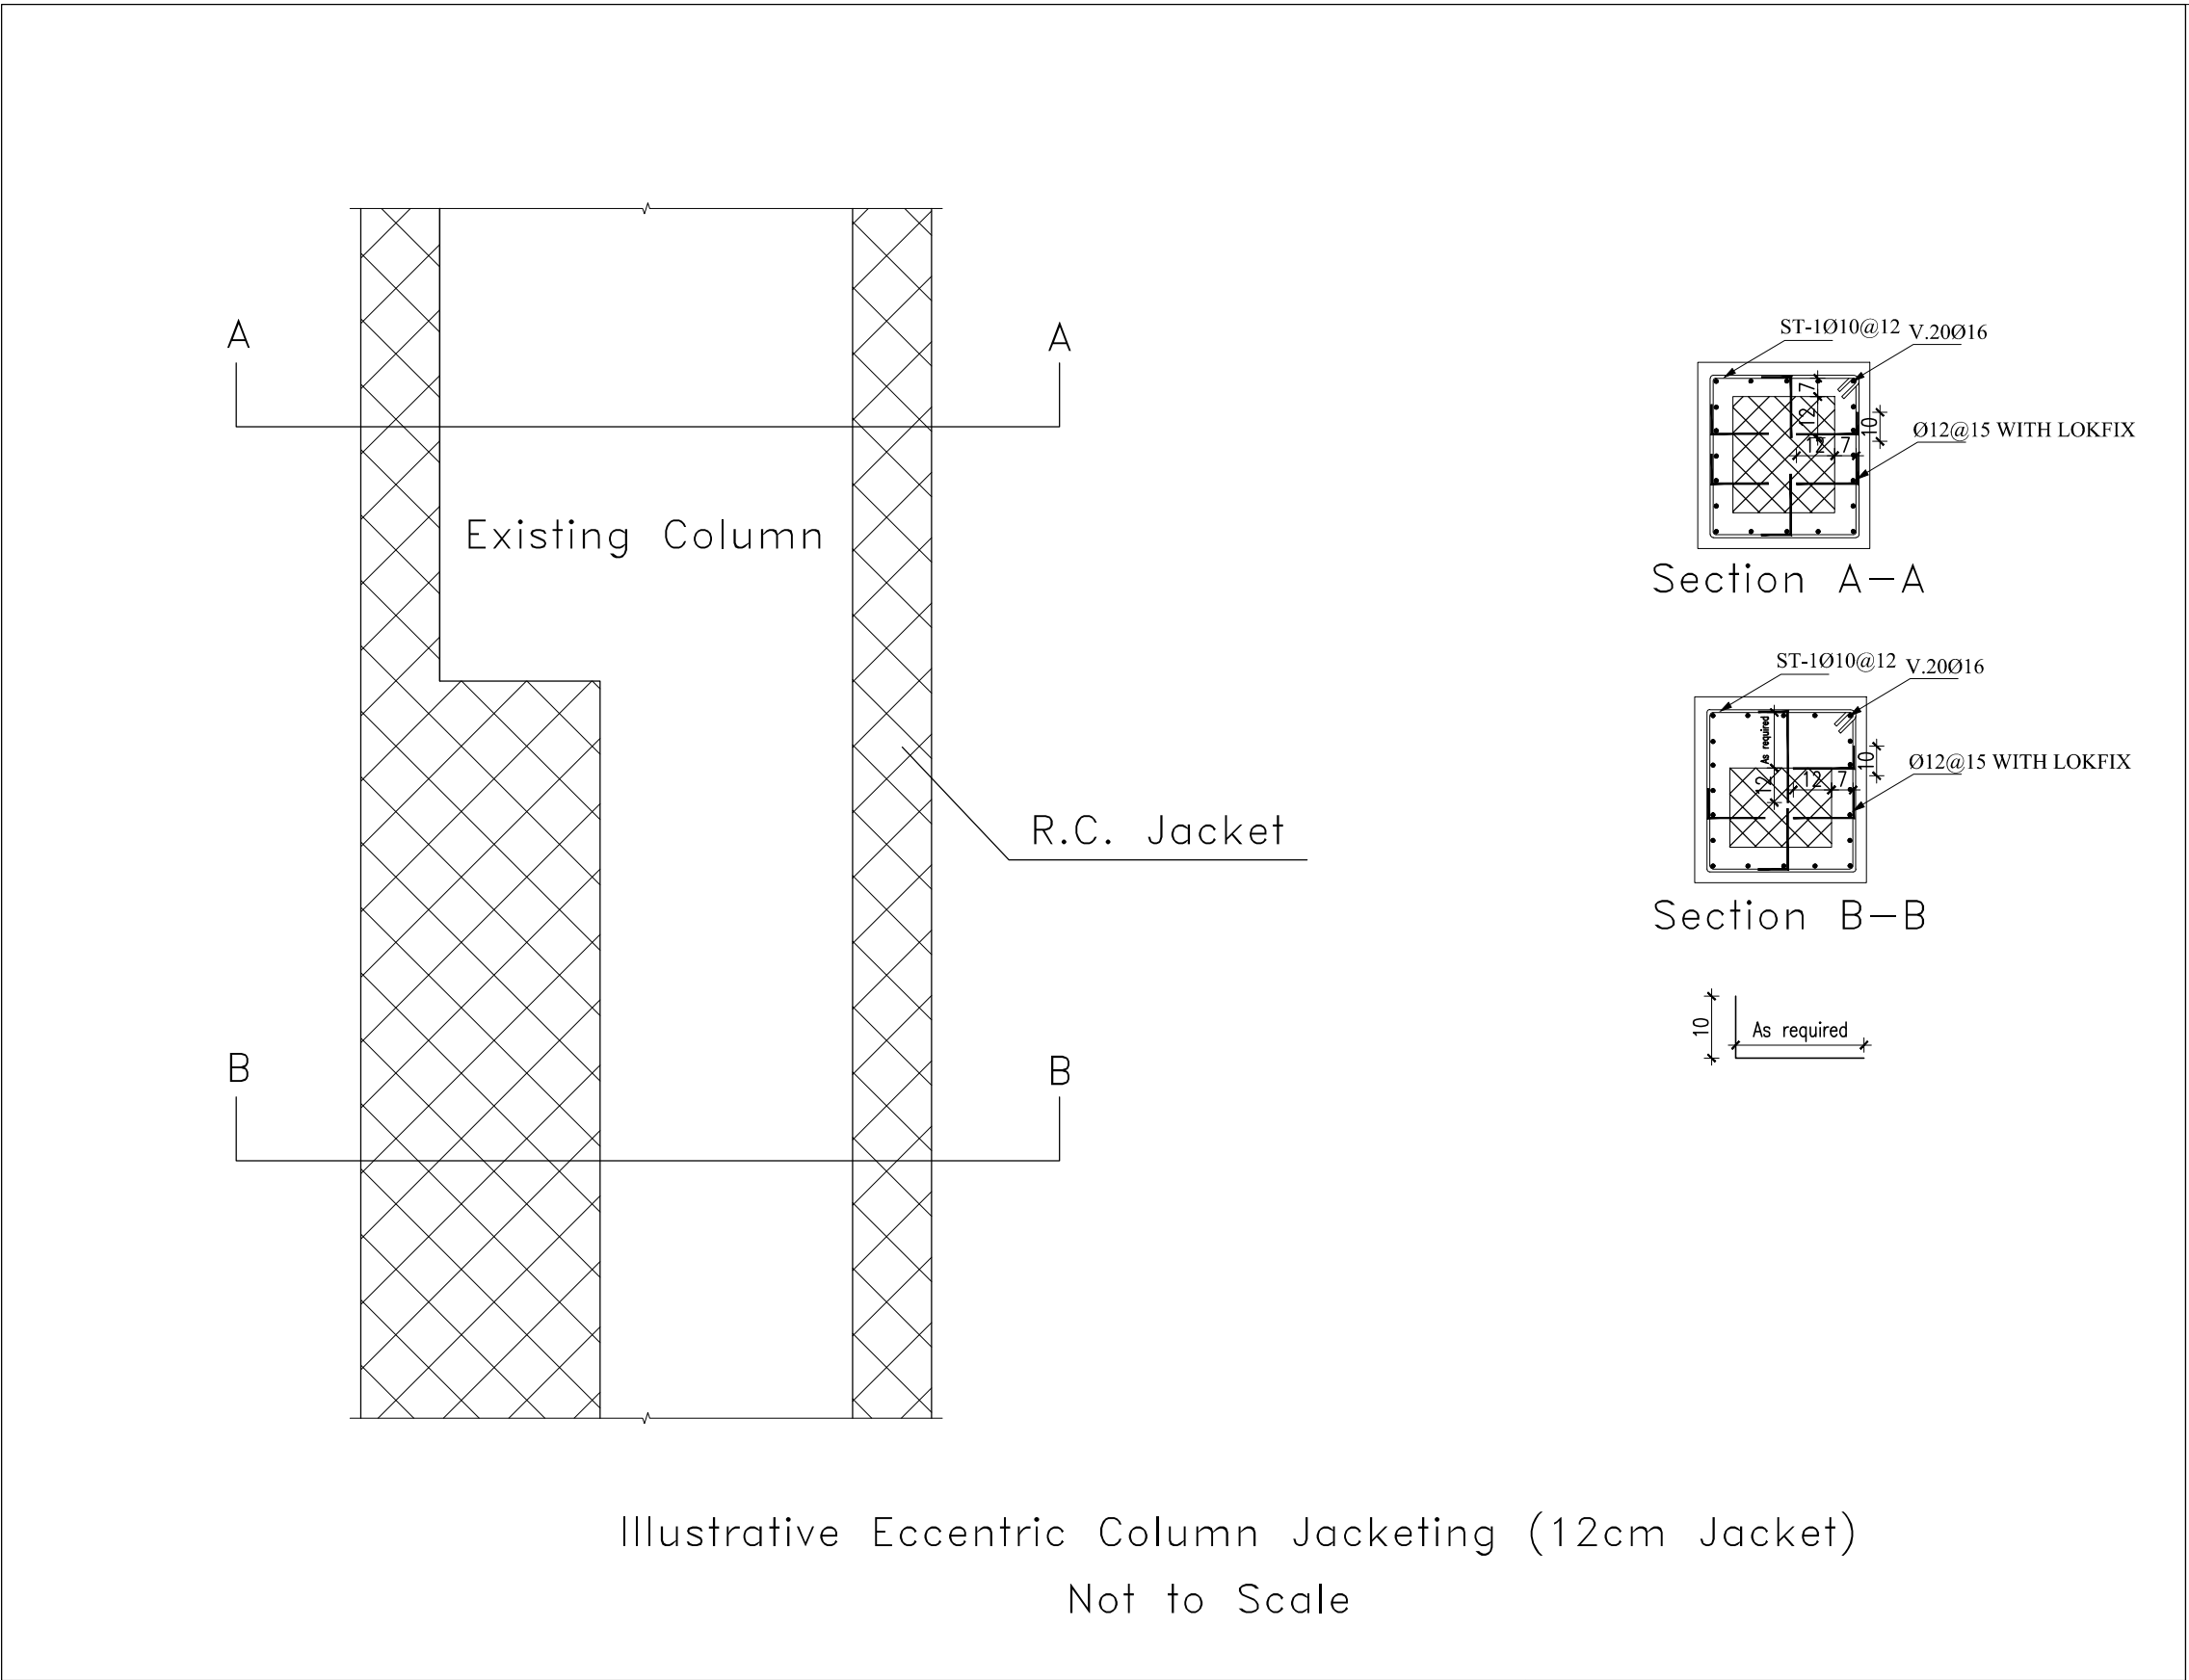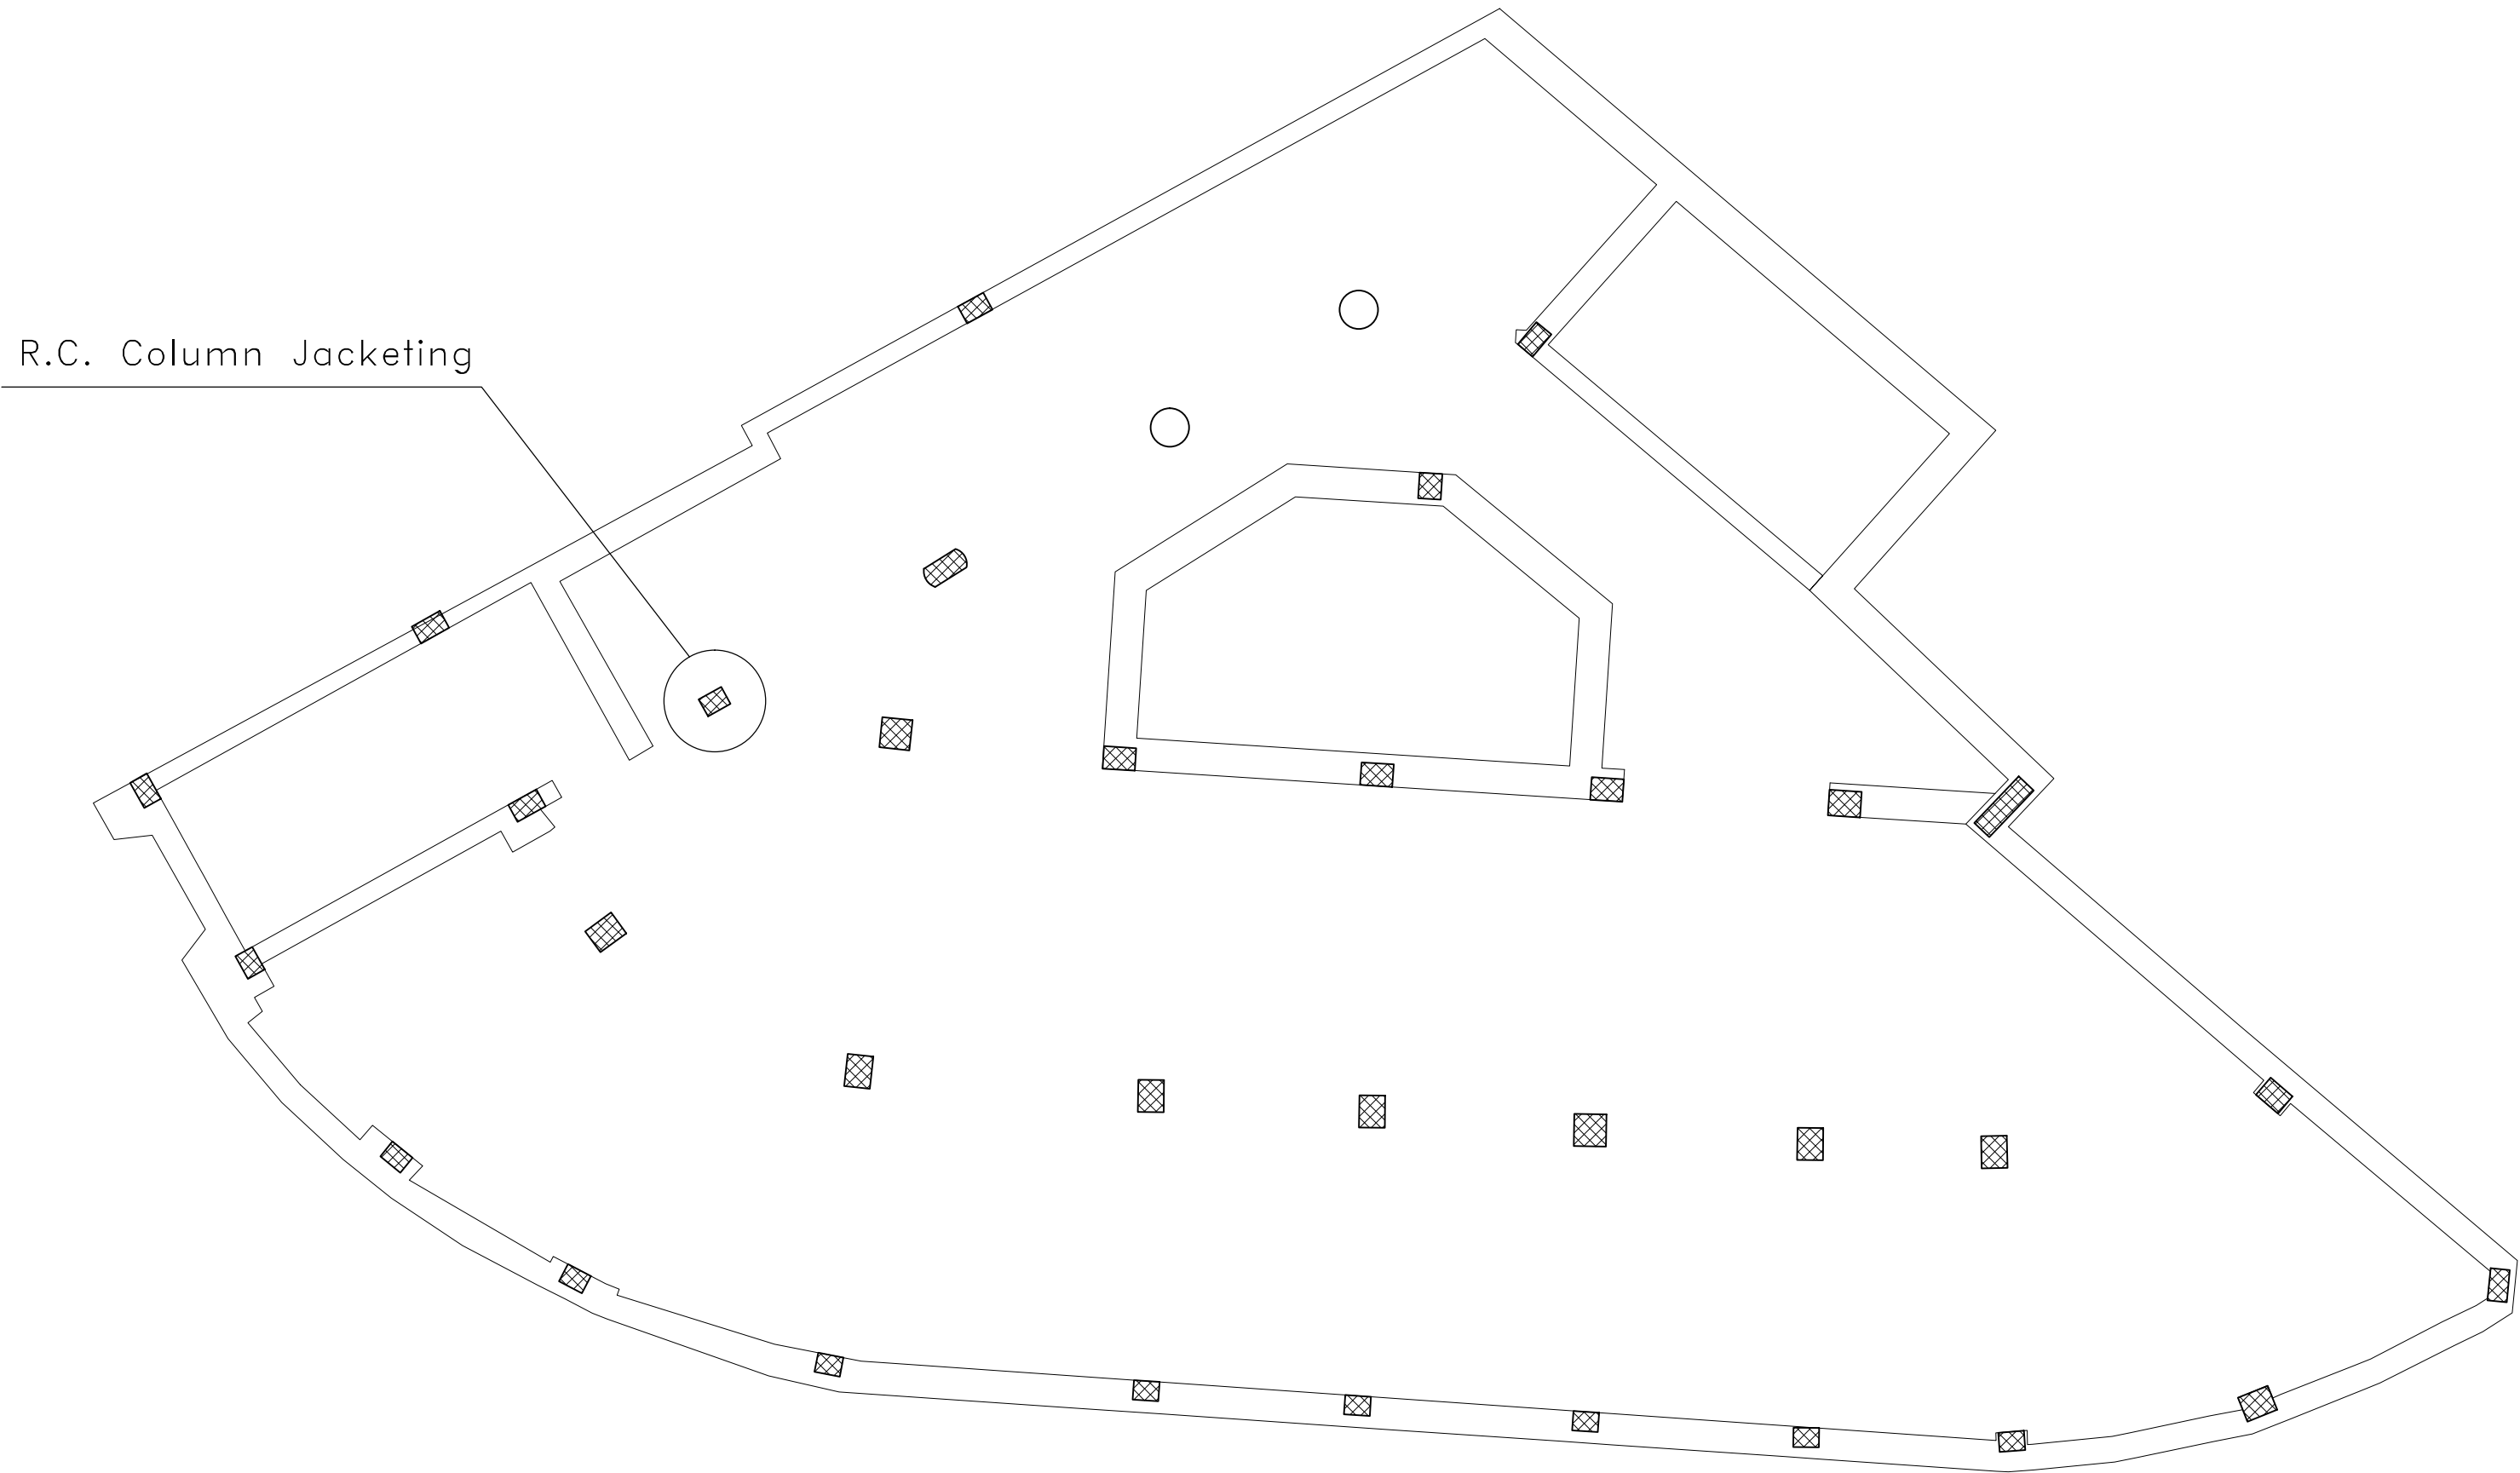

دائرة الأرفاف الإسلامية في القدس



NORTH

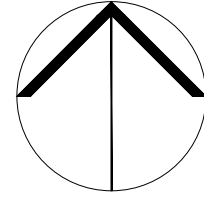

03			
02			
01			
REV.	SUBJECT	DATE	BY

NOTES:
- Levels in meters.
.....
.....


- LEGEND:
- ABBREVIATIONS:
 - F = FOUNDATION
 - C = COLUMN
 - SF = SHEAR WALL FOUNDATION
 - GB = GROUND BEAM
 - D = DEPTH
 - SL = STIRRUPS
 - V = VERTICAL STEEL
 - H = HORIZONTAL STEEL
 - T = TOP STEEL
 - B = BOTTOM STEEL
 - M = MIDDLE STEEL
 - L = LENGTH
 - # = HIGH YIELD BARS.
 - S.L. = SLAB LEVEL.
 - R.L. = REDUCE LEVEL
 - B.O.F. = BOTTOM OF FOUNDATION
 - EX.L. = EXCAVATION LEVEL
 - S.O.G. = SLAB ON GRADE
 - W. = WALL
 - F.C.L. = FINISH CONCRETE LEVEL
 - U.O.N. = UNLESS OTHER NOTED
 - N.F. = Near Fill Face
 - F.F. = Far Fill Face
 - REINFORCING STEEL STRENGTH :-
 - Fy = 414 MPa
 - CONCRETE STRENGTH :-
 - f_c'=16 Mpa FOR PLAIN CONCRETE.
 - f_c'=20 Mpa FOR SLAB ON GRADE.
 - f_c'=24 Mpa FOR SLABS & FOUNDATIONS .
 - f_c'=24 Mpa FOR COLUMNS, WALLS & GRADE BEAMS.
 - CONCRETE COVER :-
 - 70 mm FOR FOUNDATIONS.
 - 40 mm FOR COLUMNS & BEAMS.
 - 25 mm FOR SLABS .
 - FIRST STIRRUP SHALL BE LOCATED NOT MORE THAN 5cm FROM FACE OF SUPPORT.

PROJECT TITLE:
PRODUCTIVITY& URBAN RENEWAL IN EAST JERUSALEM (PURE)

Renovation Works of Building SS001

Sheet Title:
SS001 Eccentric column Jacketing Detail

CONSULTANTS:

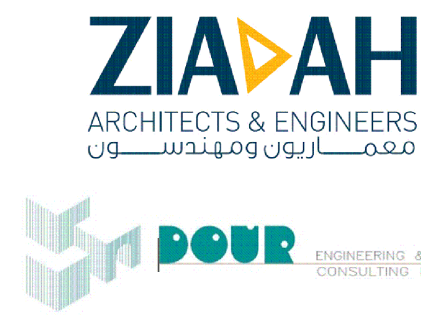

Scale 1:100 When Printed at A1 Sheet	Date 16 September 2017
Designed by: ZIADAH CONSULTANTS	Division: STRUCTURAL
Checked by: ZIADAH CONSULTANTS	Drawing No. S00
Drawn by: ZIADAH CONSULTANTS	Project No.

OWNER:

دائرة الاوقاف الاسلامية في القدس



PROJECT TITLE:

**PRODUCTIVITY AND URBAN RENEWAL IN EAST JERUSALEM
(PURE)**

Renovation Works of Buildings SS001

Mechanical Drawings

MECHANICAL DRAWINGS TABLE	
Sheet Number	Sheet Name
M0-00	LIST OF DRAWINGS
M0-0	LIST OF SYMBOLS
M0-1	HVAC LAYOUT-GROUND FLOOR
M0-2	HVAC LAYOUT-MEZZ. FLOOR
M0-3	HVAC PLAN-TOP ROOF
M0-4	ROOF DRAIN LAYOUT


دائرة الأوقاف الإسلامية في القدس



UNDP
United Nations
Development Programme



EUROPEAN UNION

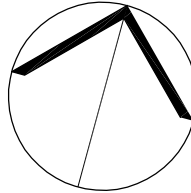

NORTH

03			
02			
01			
REV.	SUBJECT	DATE	BY

NOTES:
- All Levels in meter
- All dimensions are shown in centimeters.
.....
.....

LEGEND:

PROJECT TITLE

PRODUCTIVITY& URBAN RENEWAL
IN EAST JERUSALEM (PURE)

RENOVATION WORKS OF
BUILDING SS001

SHEET TITLE:

LIST OF DRAWINGS

 
CONSULTANTS:





ZIADAH
ARCHITECTS & ENGINEERS
مهندسون وعلماء



PCUR
ENGINEERING & PLANNING
CONSULTING ENGINEERS


Scale : 1:100 When Printed At Sheet (A1)	Date : 05/08/2017
Design by : ZIADAH CONSULTANTS	
checked by: ZIADAH CONSULTANTS	Division : MECHANICAL
Drawn by: ZIADAH CONSULTANTS	SHEET NO. M0-00
Project No. 21/16	

  VENTILATION,AC	
SYMBOL	DESCRIPTION
	INDOOR SPLIT UNIT
	IN LINE FAN
	CIRCULAR GRILLE
	INDOOR CASSETTE UNIT
	OUT DOOR UNIT
	COPPER REFRIGERANT PIPE
	4 WAY SUPPLY DIFFUSER

APPREVIATIONS	
SYMPOL	DESCRIPTION
CO	CLEAN OUT
F/A	FROM ABOVE
T/A	TO ABOVE
F/B	FROM BELOW
T/B	TO BELOW
OD	OUT DOOR UNIT
ID	IN DOOR UNIT
VD	VOLUME DAMPER
FD	FIRE DAMPER
B.S.P	BLACK STEEL PIPE
PPR	POLYPROPYLENE
PRV	PRESSURE REGULATING VALVE
NRV	NON-RETURN VALVE
IV	ISOLATING VALVE

GAS	
SYMPOL	DESCRIPTION
	GAS RISER
	GAS PIPE

FIRE FIGHTING	
SYMPOL	DESCRIPTION
	FIRE CABINET
	FIRE RISER
	BLACK STEEL PIPE
	FIRE HYDRANT CABINET
	POWER FIRE EXTINGUISHER

 SANITARY	
SYMPOL	DESCRIPTION
	FLOOR TRAP
	SEWAR RISER
	CLEAN OUT
	DRAIN MANHOLE
	CEILING CLEAN OUT
	4" HDPE PIPE
	2" HDPE PIPE
	FLOOR CLEANOUT

WATER	
SYMPOL	DESCRIPTION
	COLD WATER RISER
	WATER MANIFOLD
	HOT WATER XLPE
	COLD WATER XLPE
	COLD WATER PPR PIPE
	HOT WATER GALVANIZED PIPE


دائرة الأوقاف الإسلامية في القدس



UNDP
United Nations
Development Programme



EUROPEAN UNION

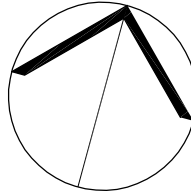

NORTH

03			
02			
01			
REV.	SUBJECT	DATE	BY

NOTES:
- All Levels in meter
- All dimensions are shown in centimeters.
.....
.....

LEGEND:

PROJECT TITLE

PRODUCTIVITY& URBAN RENEWAL
IN EAST JERUSALEM (PURE)

RENOVATION WORKS OF
BUILDING SS001

SHEET TITLE:

LIST OF SYMBOLS

 
CONSULTANTS:




ZIADAH
ARCHITECTS & ENGINEERS
مهندسون وعلماء




PCUR
ENGINEERING & PLANNING
CONSULTING ENGINEERS

Scale :	Date :
1:100 When Printed At Sheet (A1)	05/08/2017
Design by :	
ZIADAH CONSULTANTS	Division :
checked by:	MECHANICAL
ZIADAH CONSULTANTS	SHEET NO.
Drawn by:	M0-0
ZIADAH CONSULTANTS	
Project No. 21/16	

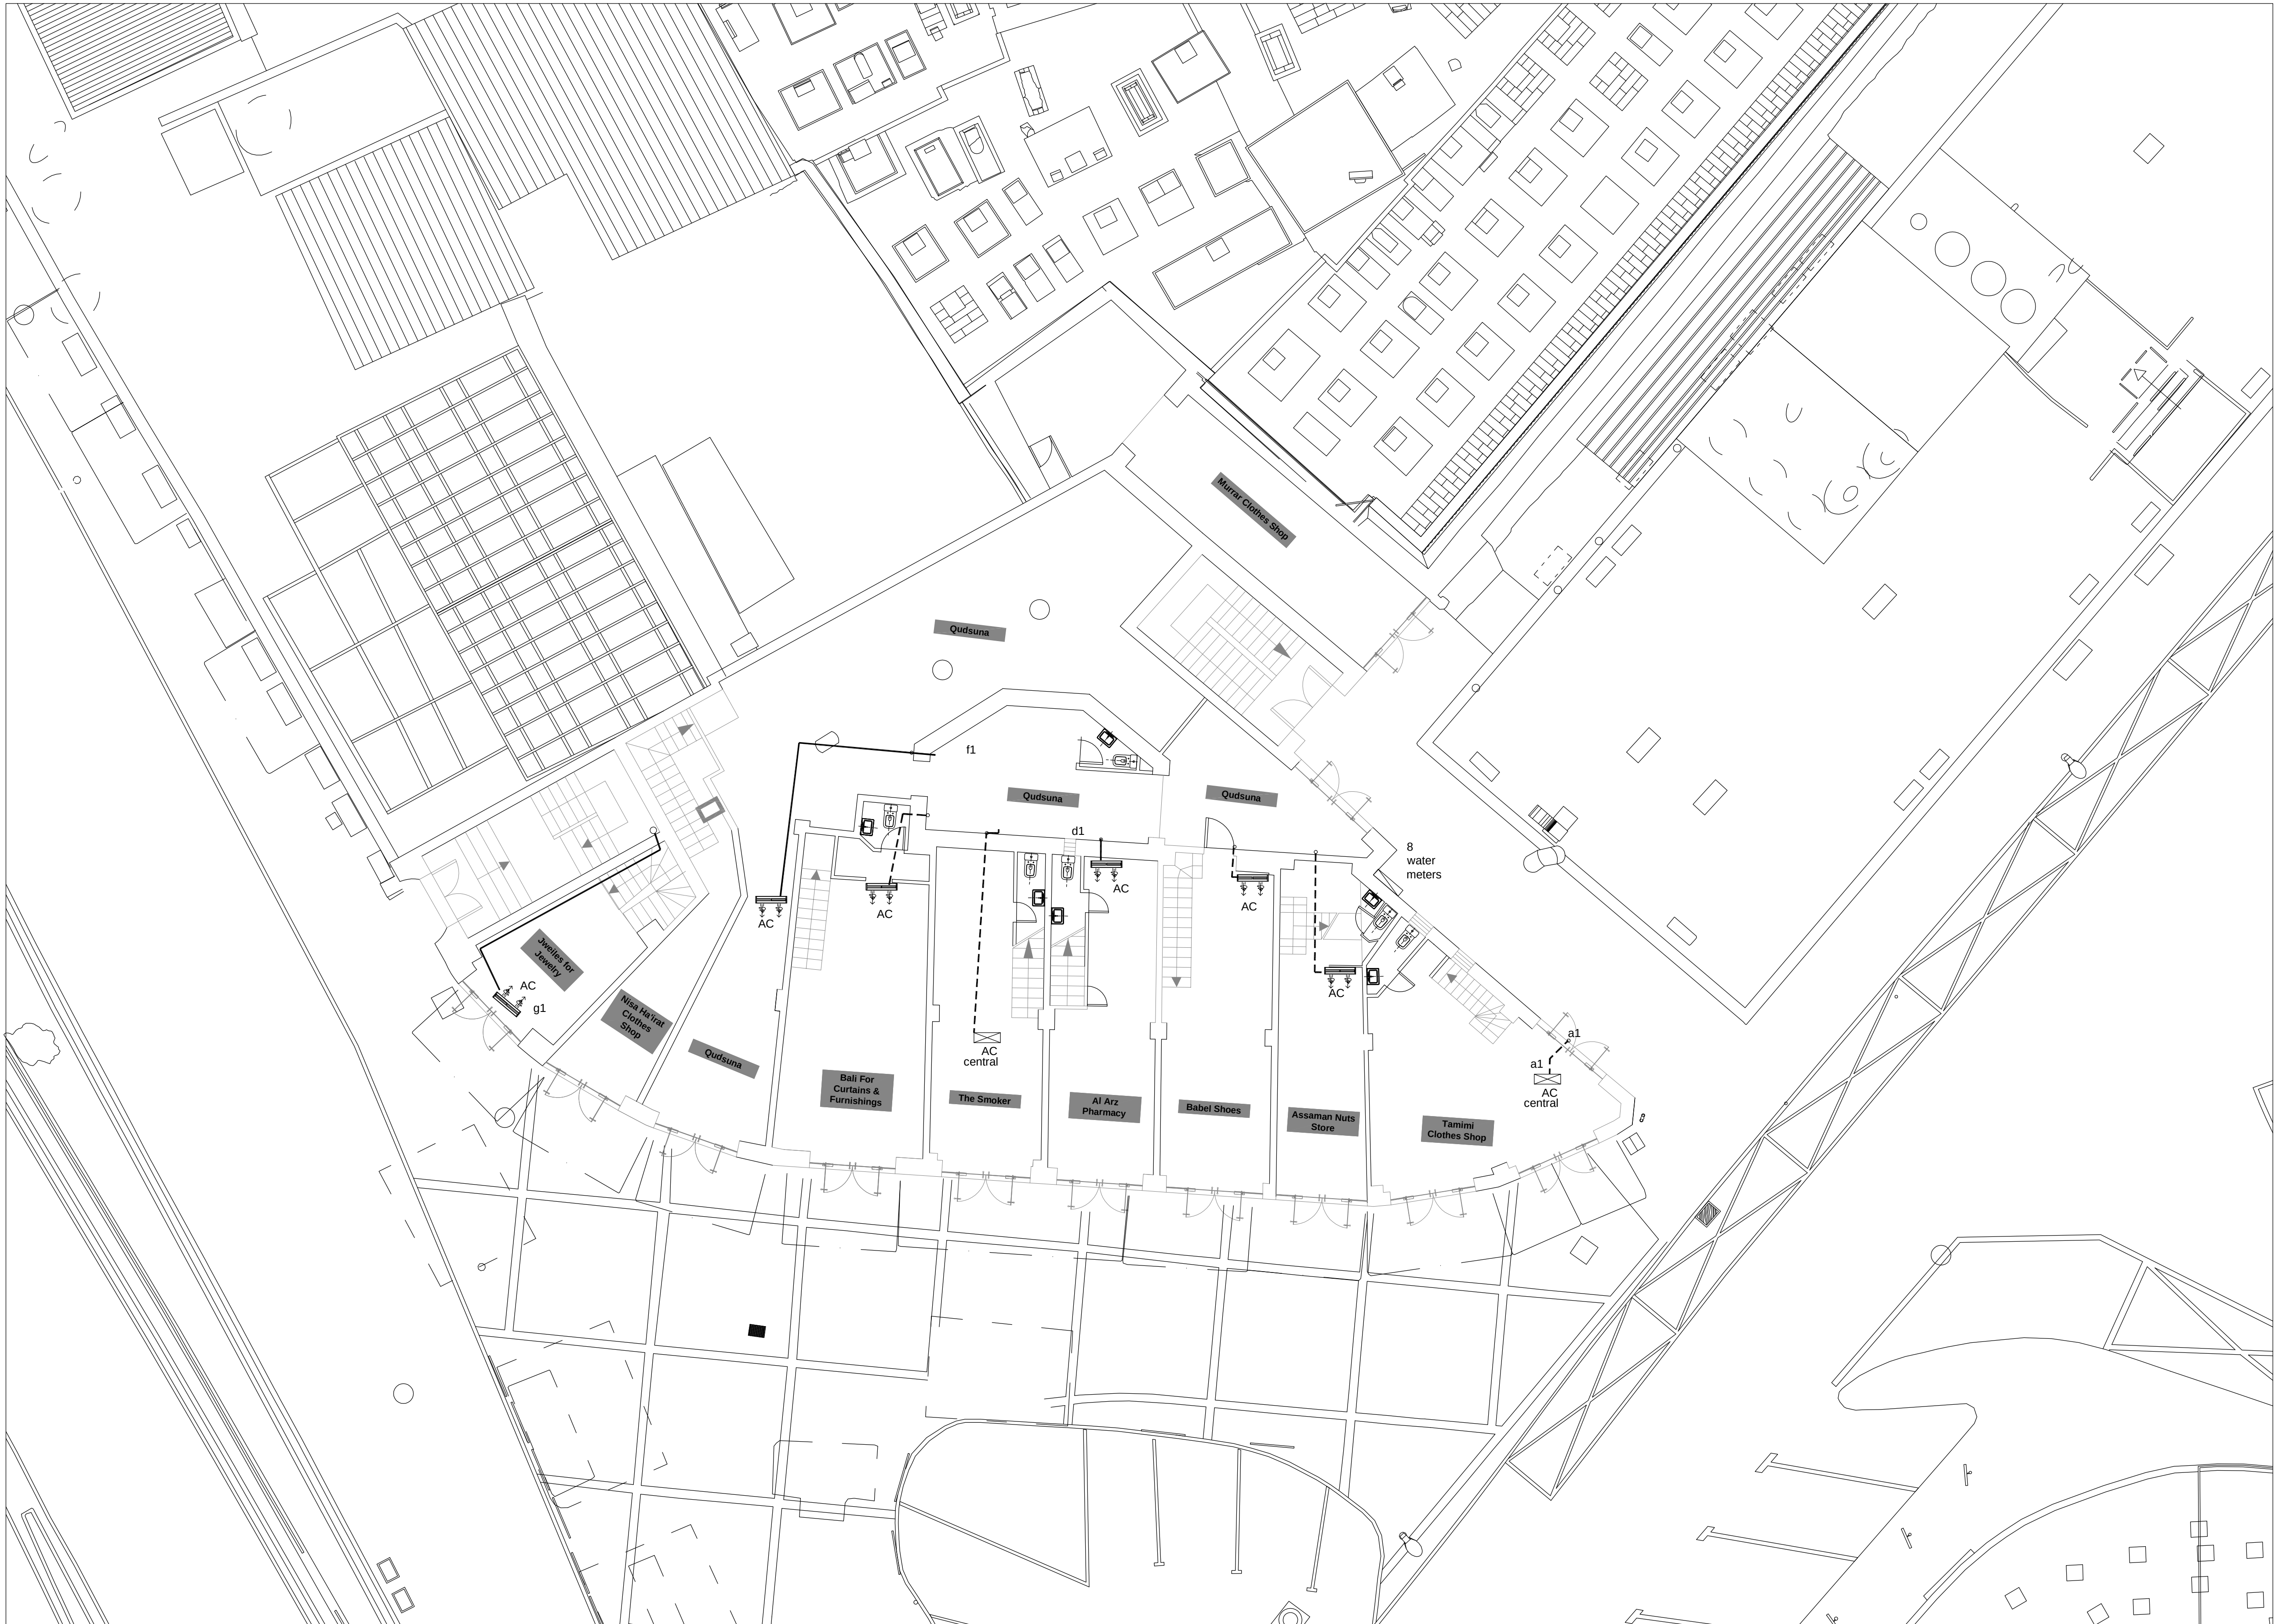

دائرة الأوقاف الإسلامية في القدس

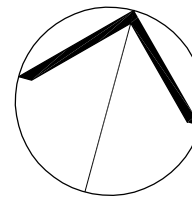

NORTH

03			
02			
01			
REV.	SUBJECT	DATE	BY

NOTES:
- All Levels in meter
- All dimensions are shown in centimeters.
.....
.....


LEGEND:

PROJECT TITLE
PRODUCTIVITY& URBAN RENEWAL
IN EAST JERUSALEM (PURE)
RENOVATION WORKS OF
BUILDING SS001


SHEET TITLE:
HVAC LAYOUT-
GROUND FLOOR

CONSULTANTS:
ZIADAH
ARCHITECTS & ENGINEERS
مهندسون ومهندسون
POUR
ENGINEERING & PLANNING
CONSULTING ENGINEERS

Scale : 1:100 When Printed At Sheet (A1)	Date : 05/08/2017
Design by : ZIADAH CONSULTANTS	Division : MECHANICAL
checked by: ZIADAH CONSULTANTS	SHEET NO. M0-1
Drawn by: ZIADAH CONSULTANTS	
Project No. 21/16	

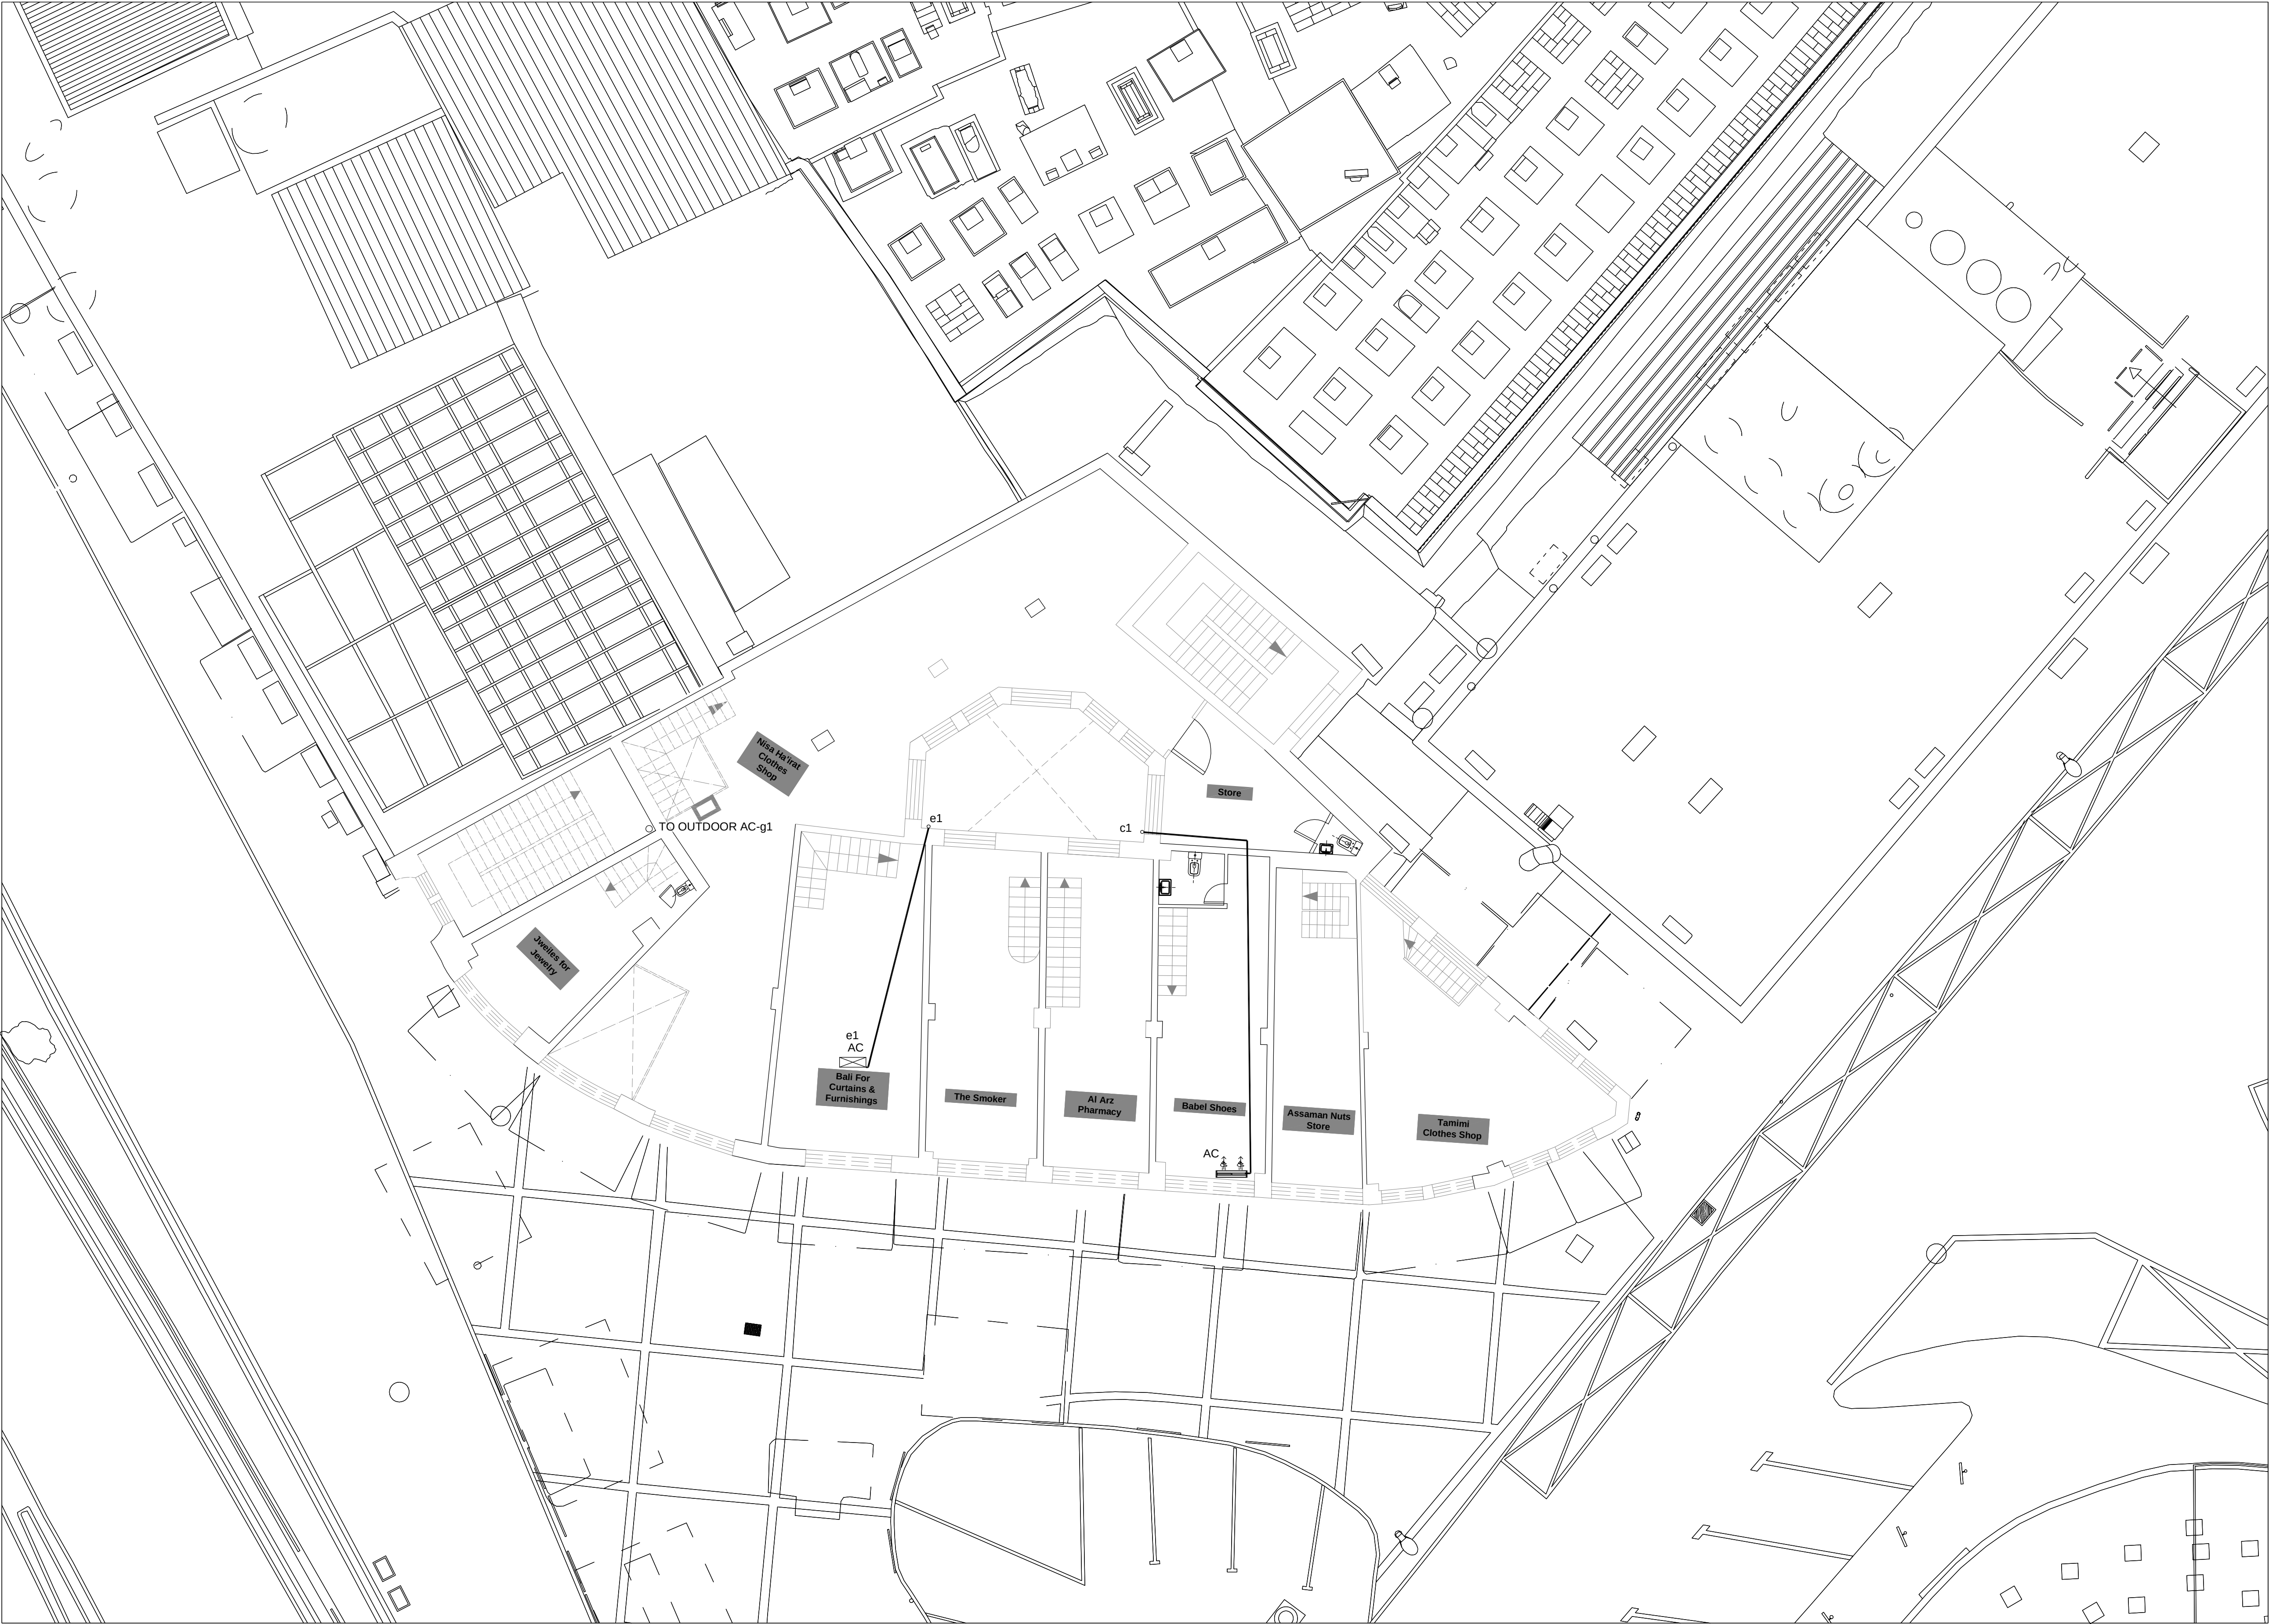

دائرة الأوقاف الإسلامية في القدس

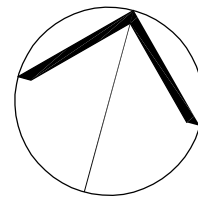

NORTH

03			
02			
01			
REV.	SUBJECT	DATE	BY

NOTES:
- All Levels in meter
- All dimensions are shown in centimeters.
.....
.....


LEGEND:

PROJECT TITLE
PRODUCTIVITY& URBAN RENEWAL
IN EAST JERUSALEM (PURE)
RENOVATION WORKS OF
BUILDING SS001


SHEET TITLE:
HVAC LAYOUT-
MEZZ FLOOR

CONSULTANTS:
ZIADAH
ARCHITECTS & ENGINEERS
مهندسون ومهندسون
POUR
ENGINEERING & PLANNING
CONSULTING ENGINEERS

Scale : 1:100 When Printed At Sheet (A3)	Date : 05/08/2017
Design by : ZIADAH CONSULTANTS	Division : MECHANICAL
checked by: ZIADAH CONSULTANTS	SHEET NO. M0-2
Drawn by: ZIADAH CONSULTANTS	
Project No. 21/16	

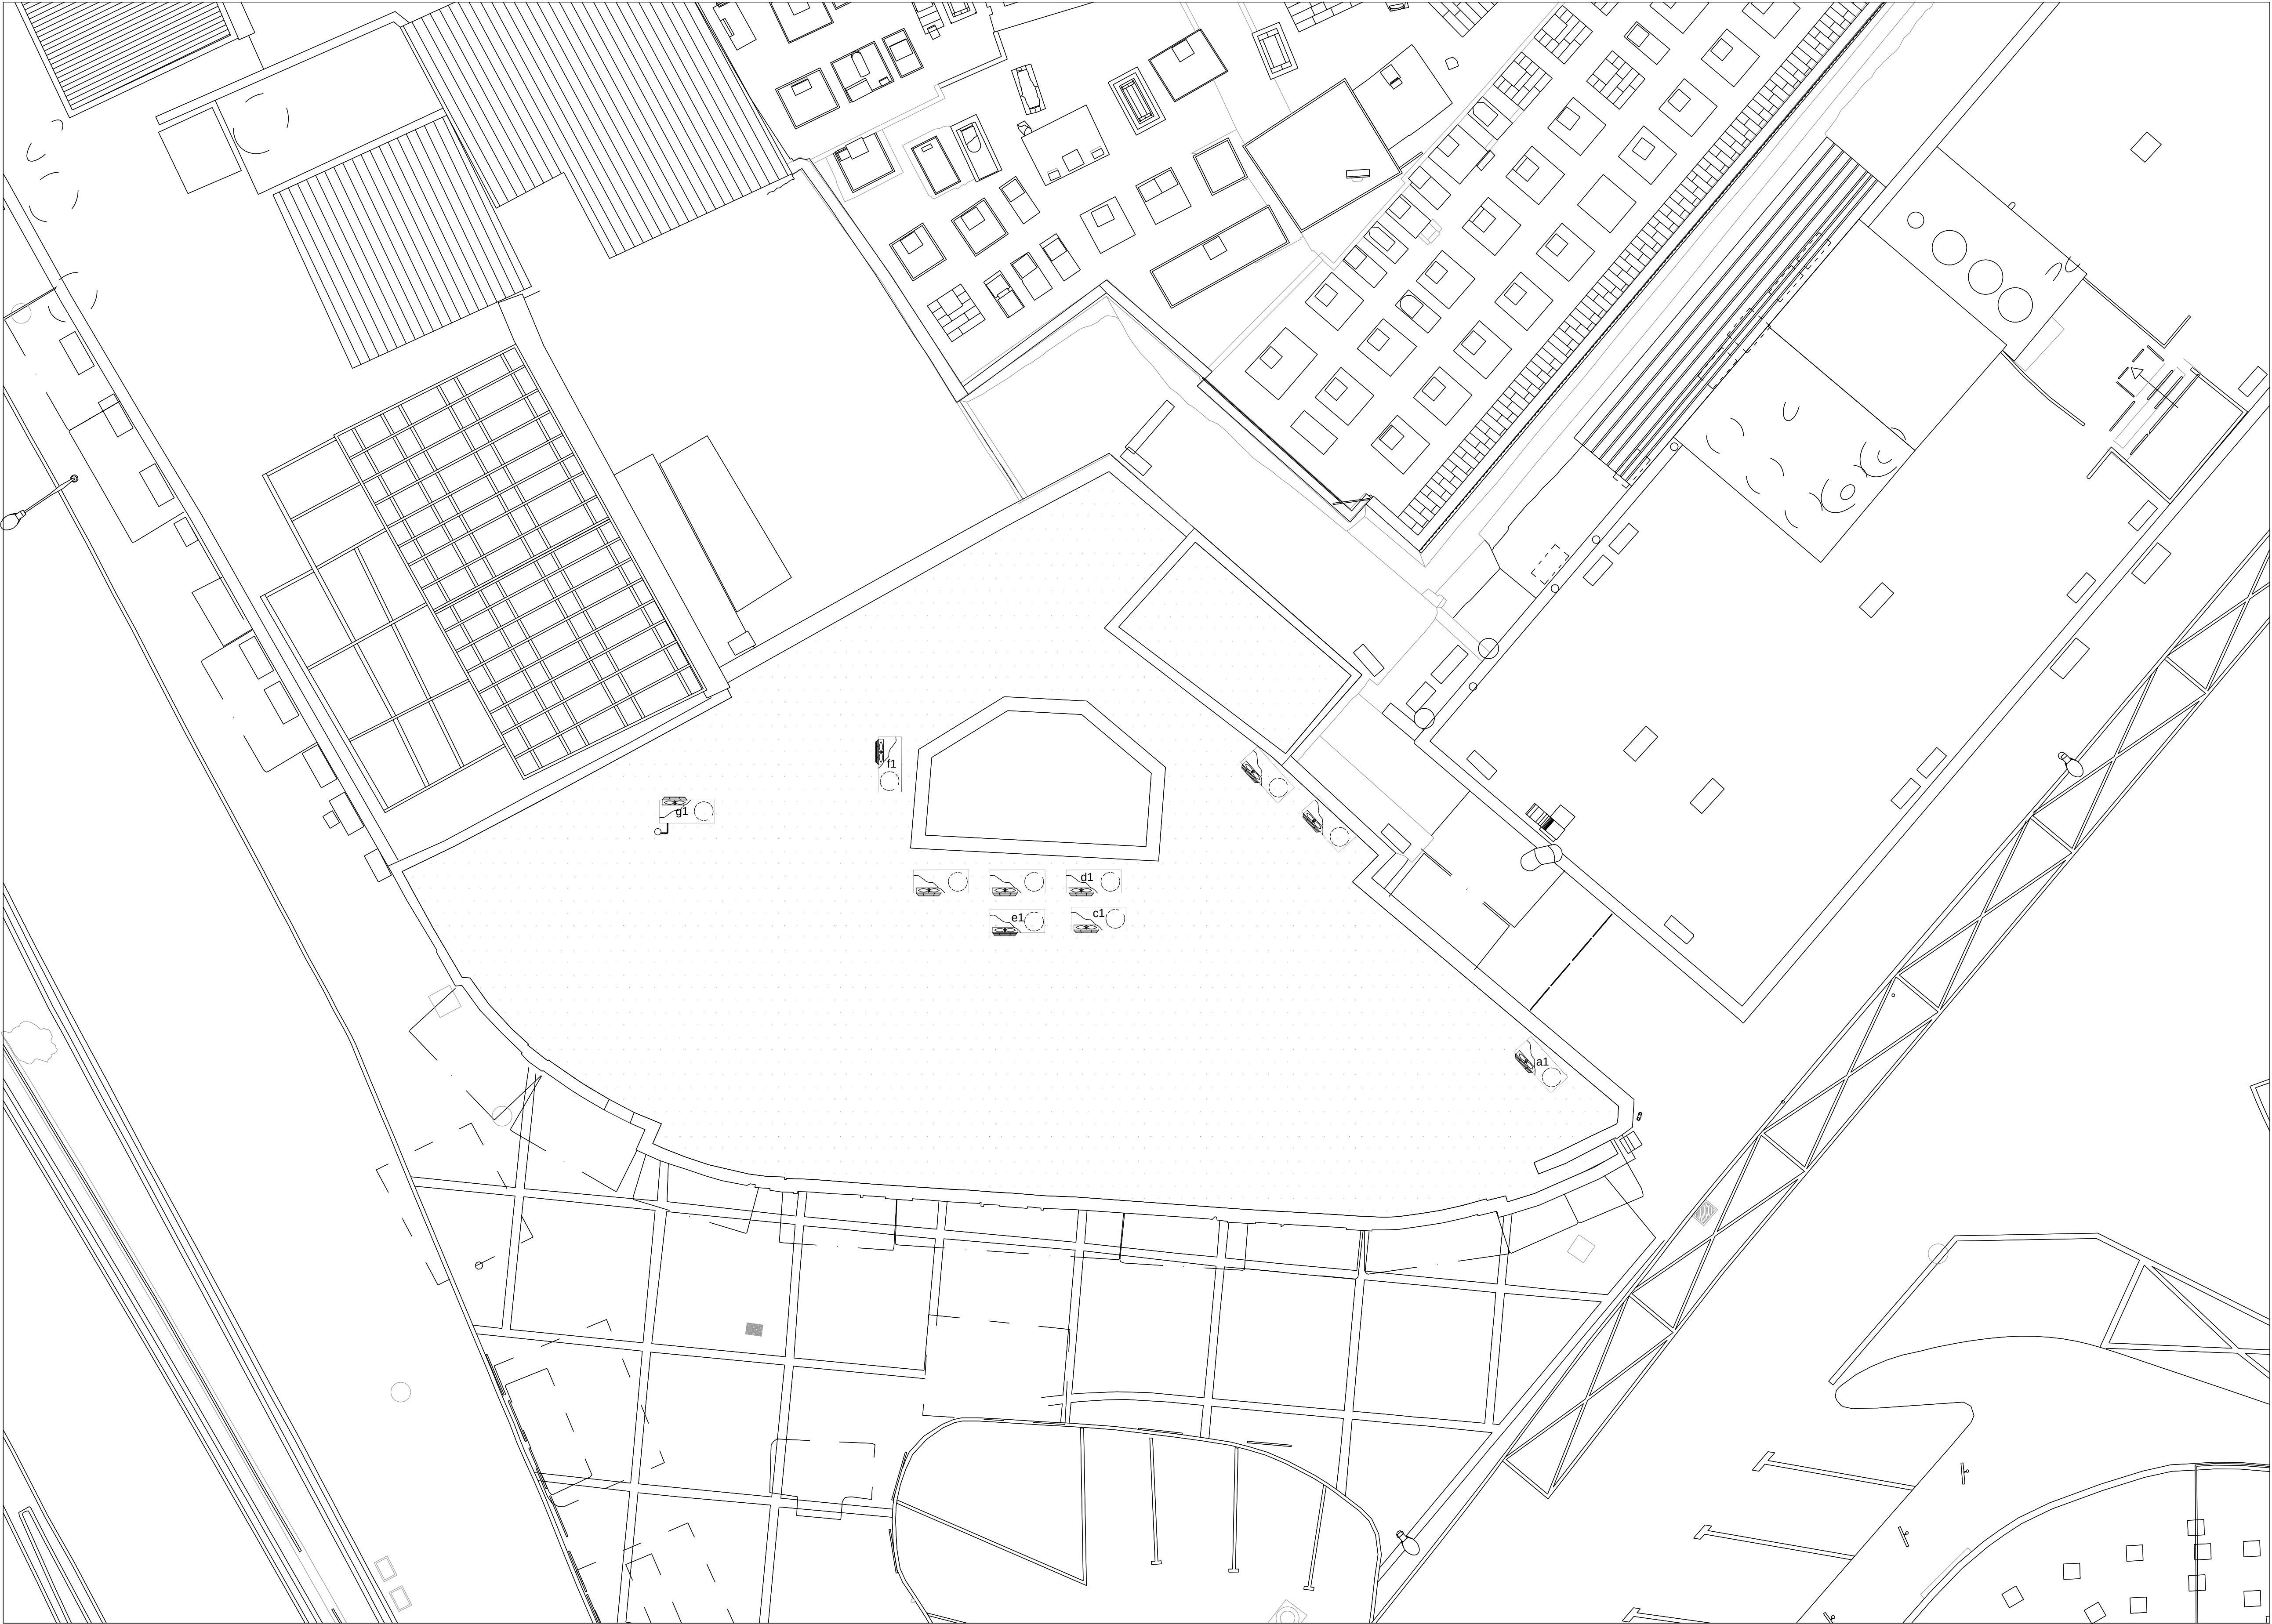

دائرة الأوقاف الإسلامية في القدس

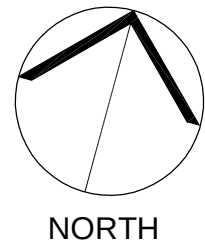

03			
02			
01			
REV.	SUBJECT	DATE	BY

NOTES:
- All Levels in meter
- All dimensions are shown in centimeters.
.....
.....

LEGEND:


PROJECT TITLE
PRODUCTIVITY& URBAN RENEWAL
IN EAST JERUSALEM (PURE)

RENOVATION WORKS OF
BUILDING SS001


SHEET TITLE:
**HVAC PLAN
TOP ROOF PLAN**

CONSULTANTS:
ZIADAH
ARCHITECTS & ENGINEERS
مهندسون وعلماء
POUR
ENGINEERING & PLANNING
CONSULTING ENGINEERS

Scale : 1:100 When Printed At Sheet (A1)	Date : 05/08/2017
Design by : ZIADAH CONSULTANTS	
checked by: ZIADAH CONSULTANTS	Division : MECHANICAL
Drawn by: ZIADAH CONSULTANTS	SHEET NO. M0-3
Project No. 21/16	

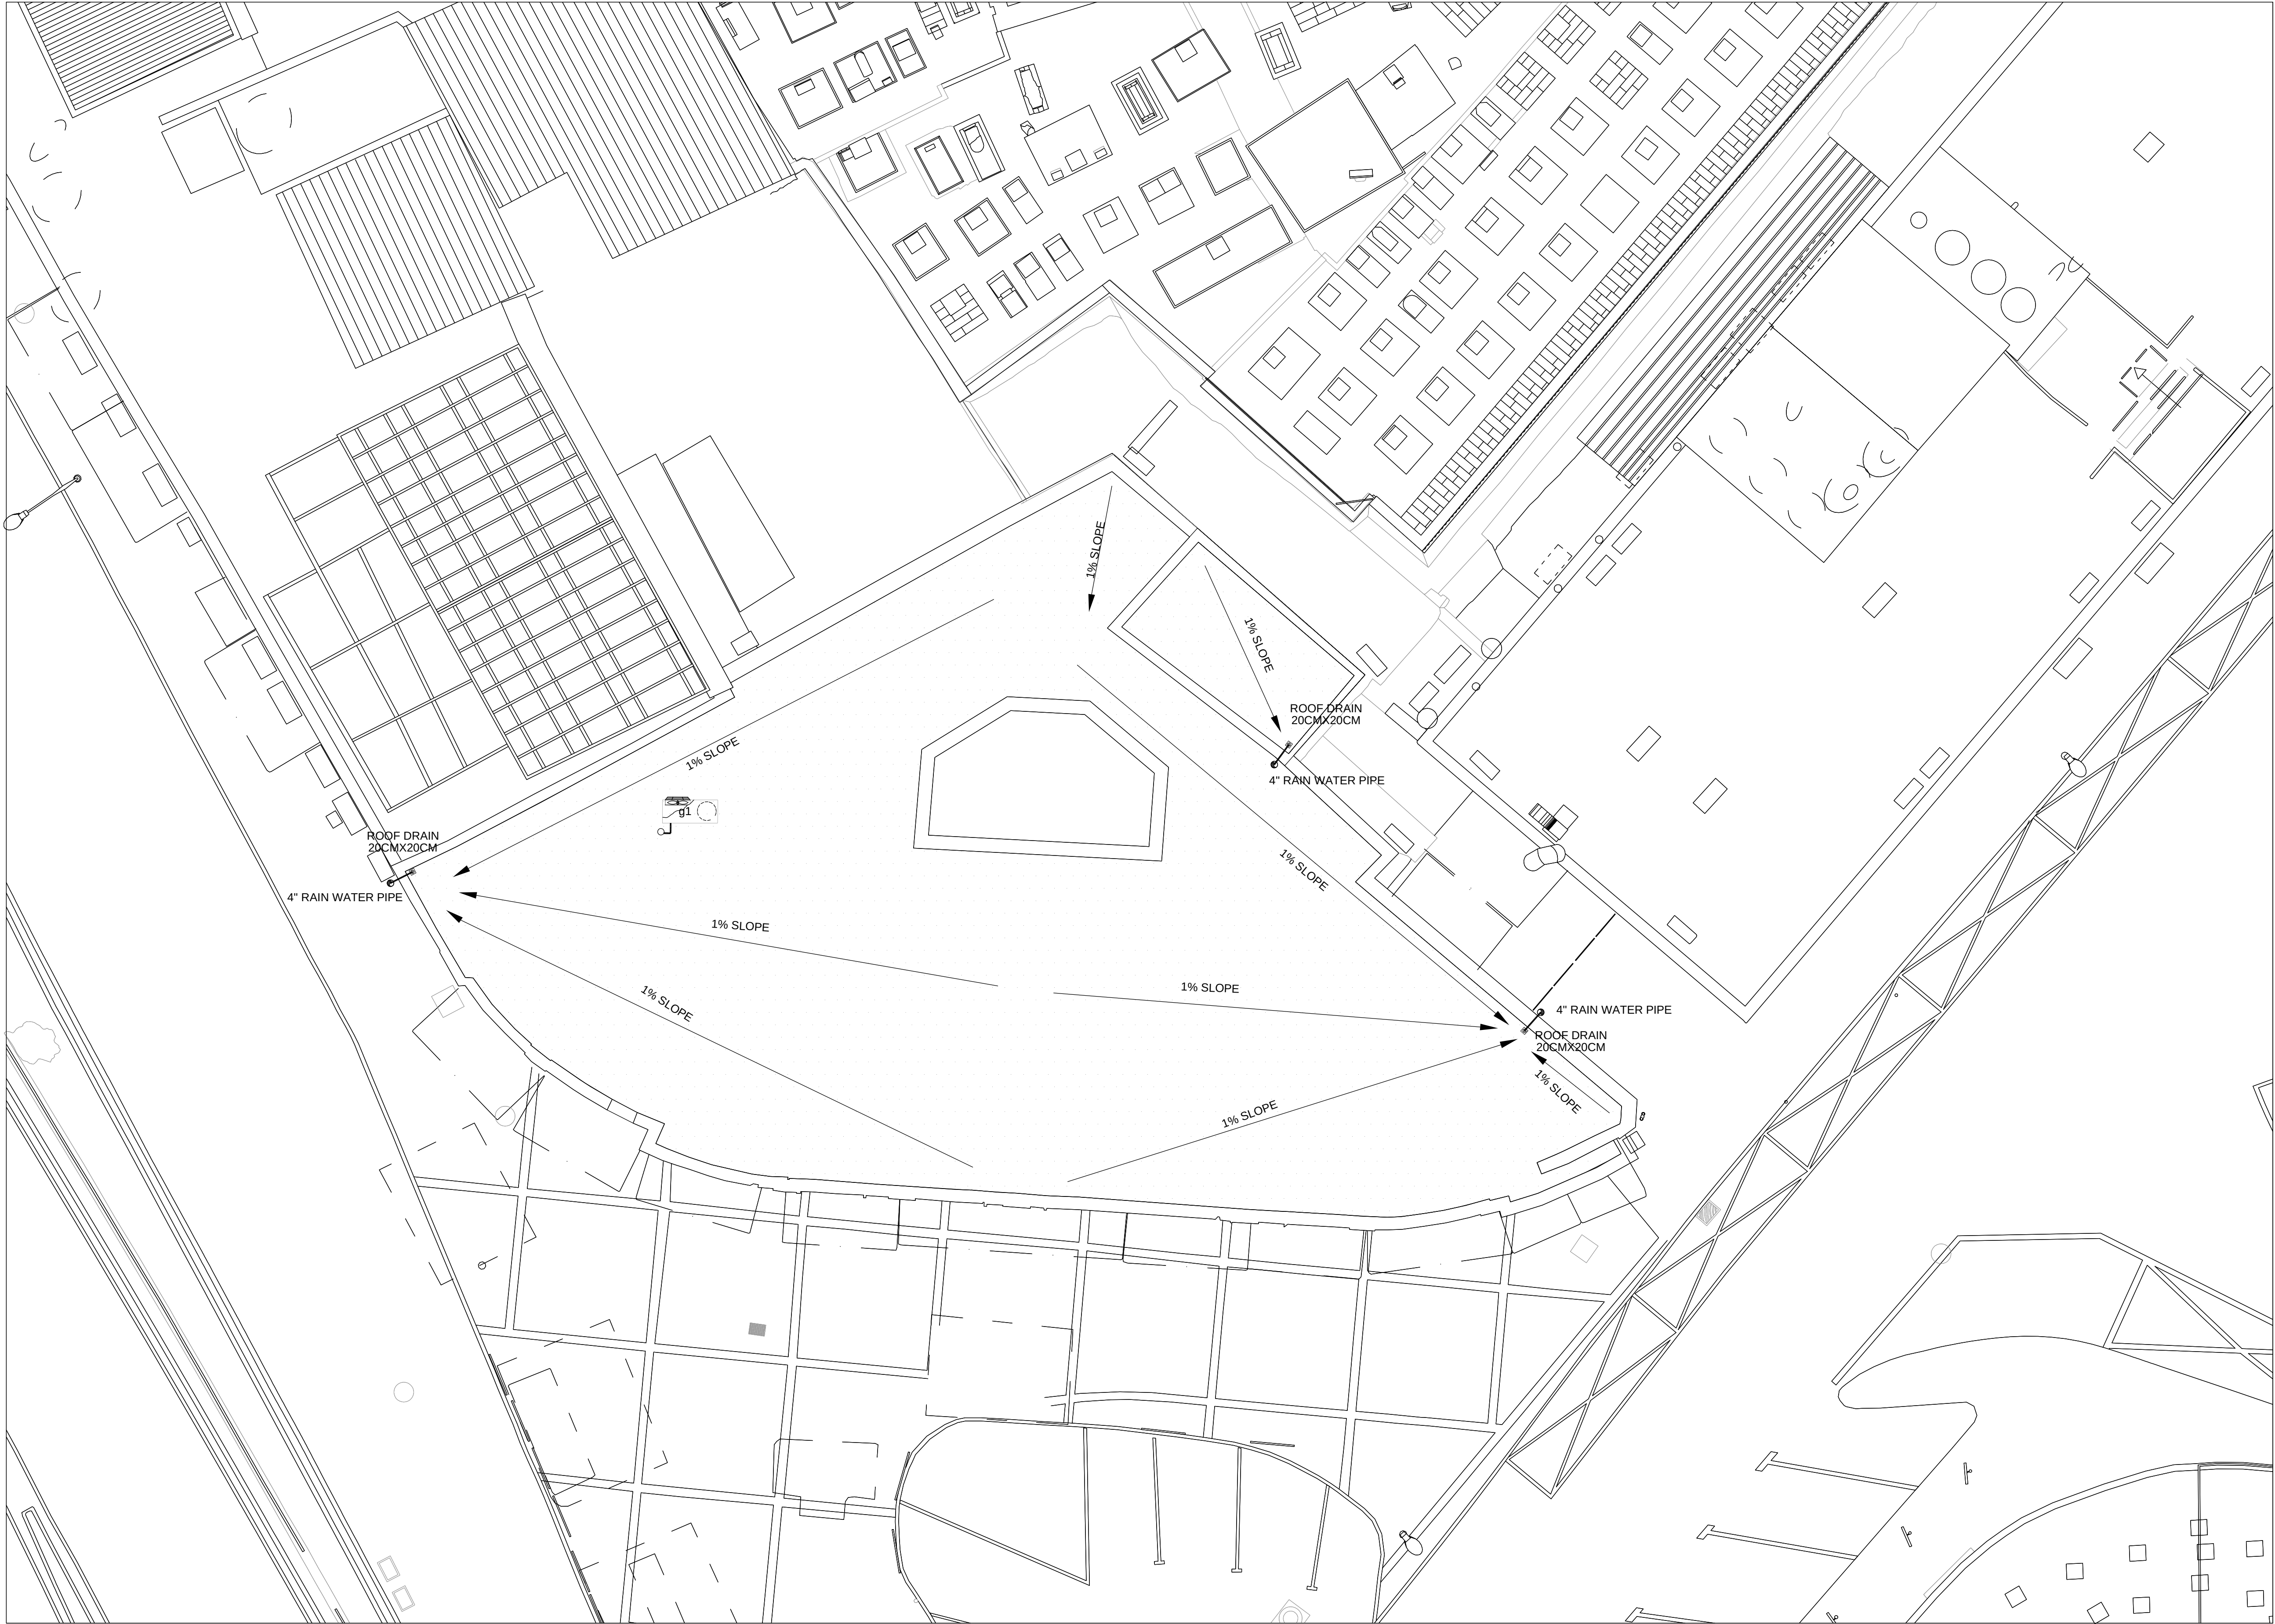

دائرة الأوقاف الإسلامية في القدس

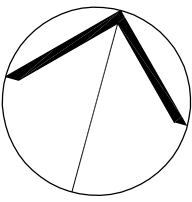

NORTH

03			
02			
01			
REV.	SUBJECT	DATE	BY

NOTES:
- All Levels in meter
- All dimensions are shown in centimeters.
.....
.....

LEGEND:

PROJECT TITLE
PRODUCTIVITY& URBAN RENEWAL
IN EAST JERUSALEM (PURE)

RENOVATION WORKS OF
BUILDING SS001


SHEET TITLE:
ROOF DRAIN LAYOUT

CONSULTANTS:
ZIADAH
ARCHITECTS & ENGINEERS
مهندسون وعلماء
POUR
ENGINEERING & PLANNING
CONSULTING ENGINEERS

Scale : 1:100 When Printed At Sheet (A1)	Date : 05/08/2017
Design by : ZIADAH CONSULTANTS	
checked by: ZIADAH CONSULTANTS	Division : MECHANICAL
Drawn by: ZIADAH CONSULTANTS	SHEET NO. M0-4
Project No. 21/16	

ELECTRICAL DRAWINGS TABLE	
Sheet Number	Sheet Name
E00	LIST OF DRAWINGS
E01	LEGEND
E101	GROUND LEVEL-POWER POINTS PLAN
E102	MEZZANINE LEVEL-POWER POINTS PLAN
E103	ROOF LEVEL-POWER POINTS PLAN
E201	GROUND LEVEL-F.A. POINTS PLAN
E202	MEZZANINE LEVEL-F.A. POINTS PLAN
E203	FIRST LEVEL-F.A. POINTS PLAN
E301	GROUND LEVEL-L.V. POINTS PLAN
E302	MEZZANINE LEVEL-L.V. POINTS PLAN
E303	ROOF LEVEL-L.V. POINTS PLAN
E401	GROUND LEVEL-LIGHT POINTS PLAN
E402	MEZZANINE LEVEL-L.GHT POINTS PLAN
E403	ROOF LEVEL-LIGHT POINTS PLAN
E501	SCHEMATIC
E601	ELECTRICAL DETAILS

دائرة الأوقاف الإسلامية في القدس

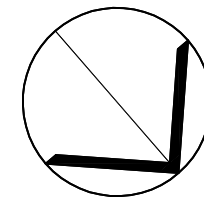

NORTH

03			
02			
01			
REV	SUBJECT	DATE	BY

NOTES:

LEGEND:

PROJECT TITLE

PRODUCTIVITY& URBAN RENEVAL
IN EAST JERUSALEM (PURE)

RENOVATION WORKS OF
BUILDING SS001

SHEET TITLE:

Electrical Index

CONSULTANTS:



Scale : 1:100 When Printed At A3 Sheet	Date : 01/11/2017
Design by : ZIADAH CONSULTANTS	Division : ELECTRICAL
checked by: ZIADAH CONSULTANTS	SHEET NO. E0-00
Drawn by: ZIADAH CONSULTANTS	
Project No:1/16	

LEGEND



 
 
 
 
 
 
 
 
 
 
 
 
 
 
 
 
 
 
 
 
 
 
 
SYMPOL	DESCRIPTION	SYMPOL	DESCRIPTION
	PUSH BUTTON SHUTTER SWITCH		6" INDOOR SIREN WITH FLASHER
	SINGLE GANGE SWITCHES/ NORMAL & WP		HEAT DETECTOR
	DOUBLE GANGES SWITCHES/ NORMAL & WP		PHOTO SMOKE DETECTOR
	TWO WAY SWITCH		CONTROL MODULE analogue addressable dual monitor module
	SINGLE POLE WITH LAMP FOR EXT.LIGHTING INTERMEDIATE SWITCH		BREAK GLASS
	HAND DRYER AC UNIT		FM 200
	SINGLE SOCKETS/ NORMAL AND WP		SMOKE DETECTOR ABOVE CEILING WITH INDICATOR
	DOUBLE SOCKETS/ NORMAL AND WP		FACP
	2-POLE ISOLATOR		EXTERNAL SIREN GAS DETECTOR
	4-POLE ISOLATOR		CLEAN AGENT ABORT BUTTON
	ELECTRICAL MOTOR		CLEAN AGENT RELEASE BUTTON
			FM200 - Clean Agent Fire Extinguishing System
	2-POLE SWITCH WITH LAMP FOR EXTERNAL SOCKETS		EARTH PIT
	VOLUME CONTROL		EARTH BUSBAR
	HORN STROBE		CHECK BOX
	CEILING MOUNTED SPEAKER		MAIN PEC
	END OF LINE		TELEPHONE HAND-HOLE
	MIC		ELECTRICAL HAND-HOLE
	DATA SOCKET		
	T.V SOCKET		KEYPAD
	TEL SOCKET		MAGNETIC LOCK
	POE POE DOME CAMERA		MOTION DETECTOR
	INTERNAL WALL MOUNTED CAMERA		
	EXTERNAL WALL MOUNTED CAMERA		
	INTERCOM KEYPAD		

PHOTO	SYMBOL	DESCRIPTION
	(A) 	A ceiling recessed LED downlight. Electronic, fixed output control gear. Body: Polycarbonate (PC), black. Reflector: satinbrite Polycarbonate (PC). Module support: white painted sheet steel. Heatsink: Aluminium, black. Class II electrical, IP20, IK03. Fixing clips suitable for ceiling thicknesses from 5-40 mm. Suitable for a variety of decorative attachments. No tools required. Cut-out Ø190 mm. Complete with 4000K LED fixed module. Dimensions: Ø205 x 150 mm, Total power: 15 W
	(B) 	<i>DITTO, but with emergency kit / 3Hrs</i>
	(C) 	IP65 dust and moisture resistant luminaire for 2 x 28W T16 lamp(s) with electronic - fixed output circuit. Class I electrical. Canopy: light grey polycarbonate, diffuser: polycarbonate with internal prisms, toggles: polycarbonate. For surface or suspended mounting.
	(D) 	<i>DITTO, but with emergency kit / 3Hrs</i>
	(E) 	A round bulkhead LED luminaire. Electronic, fixed output control gear with 3 hour, manual test, emergency lighting circuit. Body: injection moulded Polycarbonate (PC). Bezel: injection moulded Polycarbonate (PC), white finish. Diffuser: opal Polycarbonate (PC). Electrical safety class I. Ingress protection IP54. Complete with 4000K LED. Dimensions: Ø327 x 105 mm, Total power: 13 W
	(F) 	A value performance, low height, ceiling recessed LED downlight. Electronic, fixed output control gear. Body and reflector: Aluminium, powder coated white (RAL 9016). Diffuser: Polycarbonate (PC), Class II electrical, IP44, IK09. Spring clips suitable for ceiling thicknesses from 1 to 35mm. Cut-out Ø190mm. Complete with 4000K LED. Dimensions: Ø215 x 85 mm, Total power: 12.8 W.
	(G) 	A self-contained, maintained emergency exit sign for 1 x 3W LED strip giving 3 hours manual test emergency operation. IP40, Class I electrical. Body in Polycarbonate (PC), finished white. Diffuser in Polycarbonate (PC). Can be wall mounted with 20mm conduit or rear back box entry. Legend panels required to be ordered separately in either ISO or EU formats. Complete with LED strip. Dimensions: 327 x 65 x 197 mm. Total power: 3 W
	(H) 	Recessed modular luminaire for 4 x 14W T16 lamps with electronic fixed output control gear. Body in white painted steel with welded frame corners. Louvre in satinbrite aluminium with white painted infill panels. Dimensions: 597 x 597 x 59 mm

 
دائرة الأوقاف الإسلامية في القدس



هذا المشروع يدعمه من

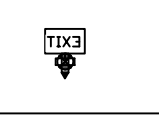

EUROPEAN UNION

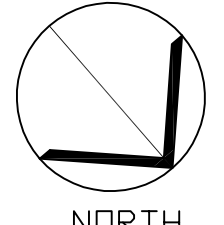

NORTH

03

02

01

REV

SUBJECT

DATE

BY

NOTES:

LEGEND:

PROJECT TITLE

PRODUCTIVITY& URBAN RENEVAL
IN EAST JERUSALEM (PURE)

RENOVATION WORKS OF
BUILDING SS001

SHEET TITLE:

Electrical Legend

CONSULTANTS:



ARCHITECTS & ENGINEERS
معماريون ومهندسون



ENGINEERING & PLANNING
CONSULTING ENGINEERS

Scale :
1:100 When Printed At A3

 
Date :
01/11/2017

Design by :
ZIADAH CONSULTANTS

checked by:
ZIADAH CONSULTANTS

Drawn by:
ZIADAH CONSULTANTS


Project No:1/16




0 10 20 30
centimeters

Division :
ELECTRICAL

SHEET NO.
E0-01

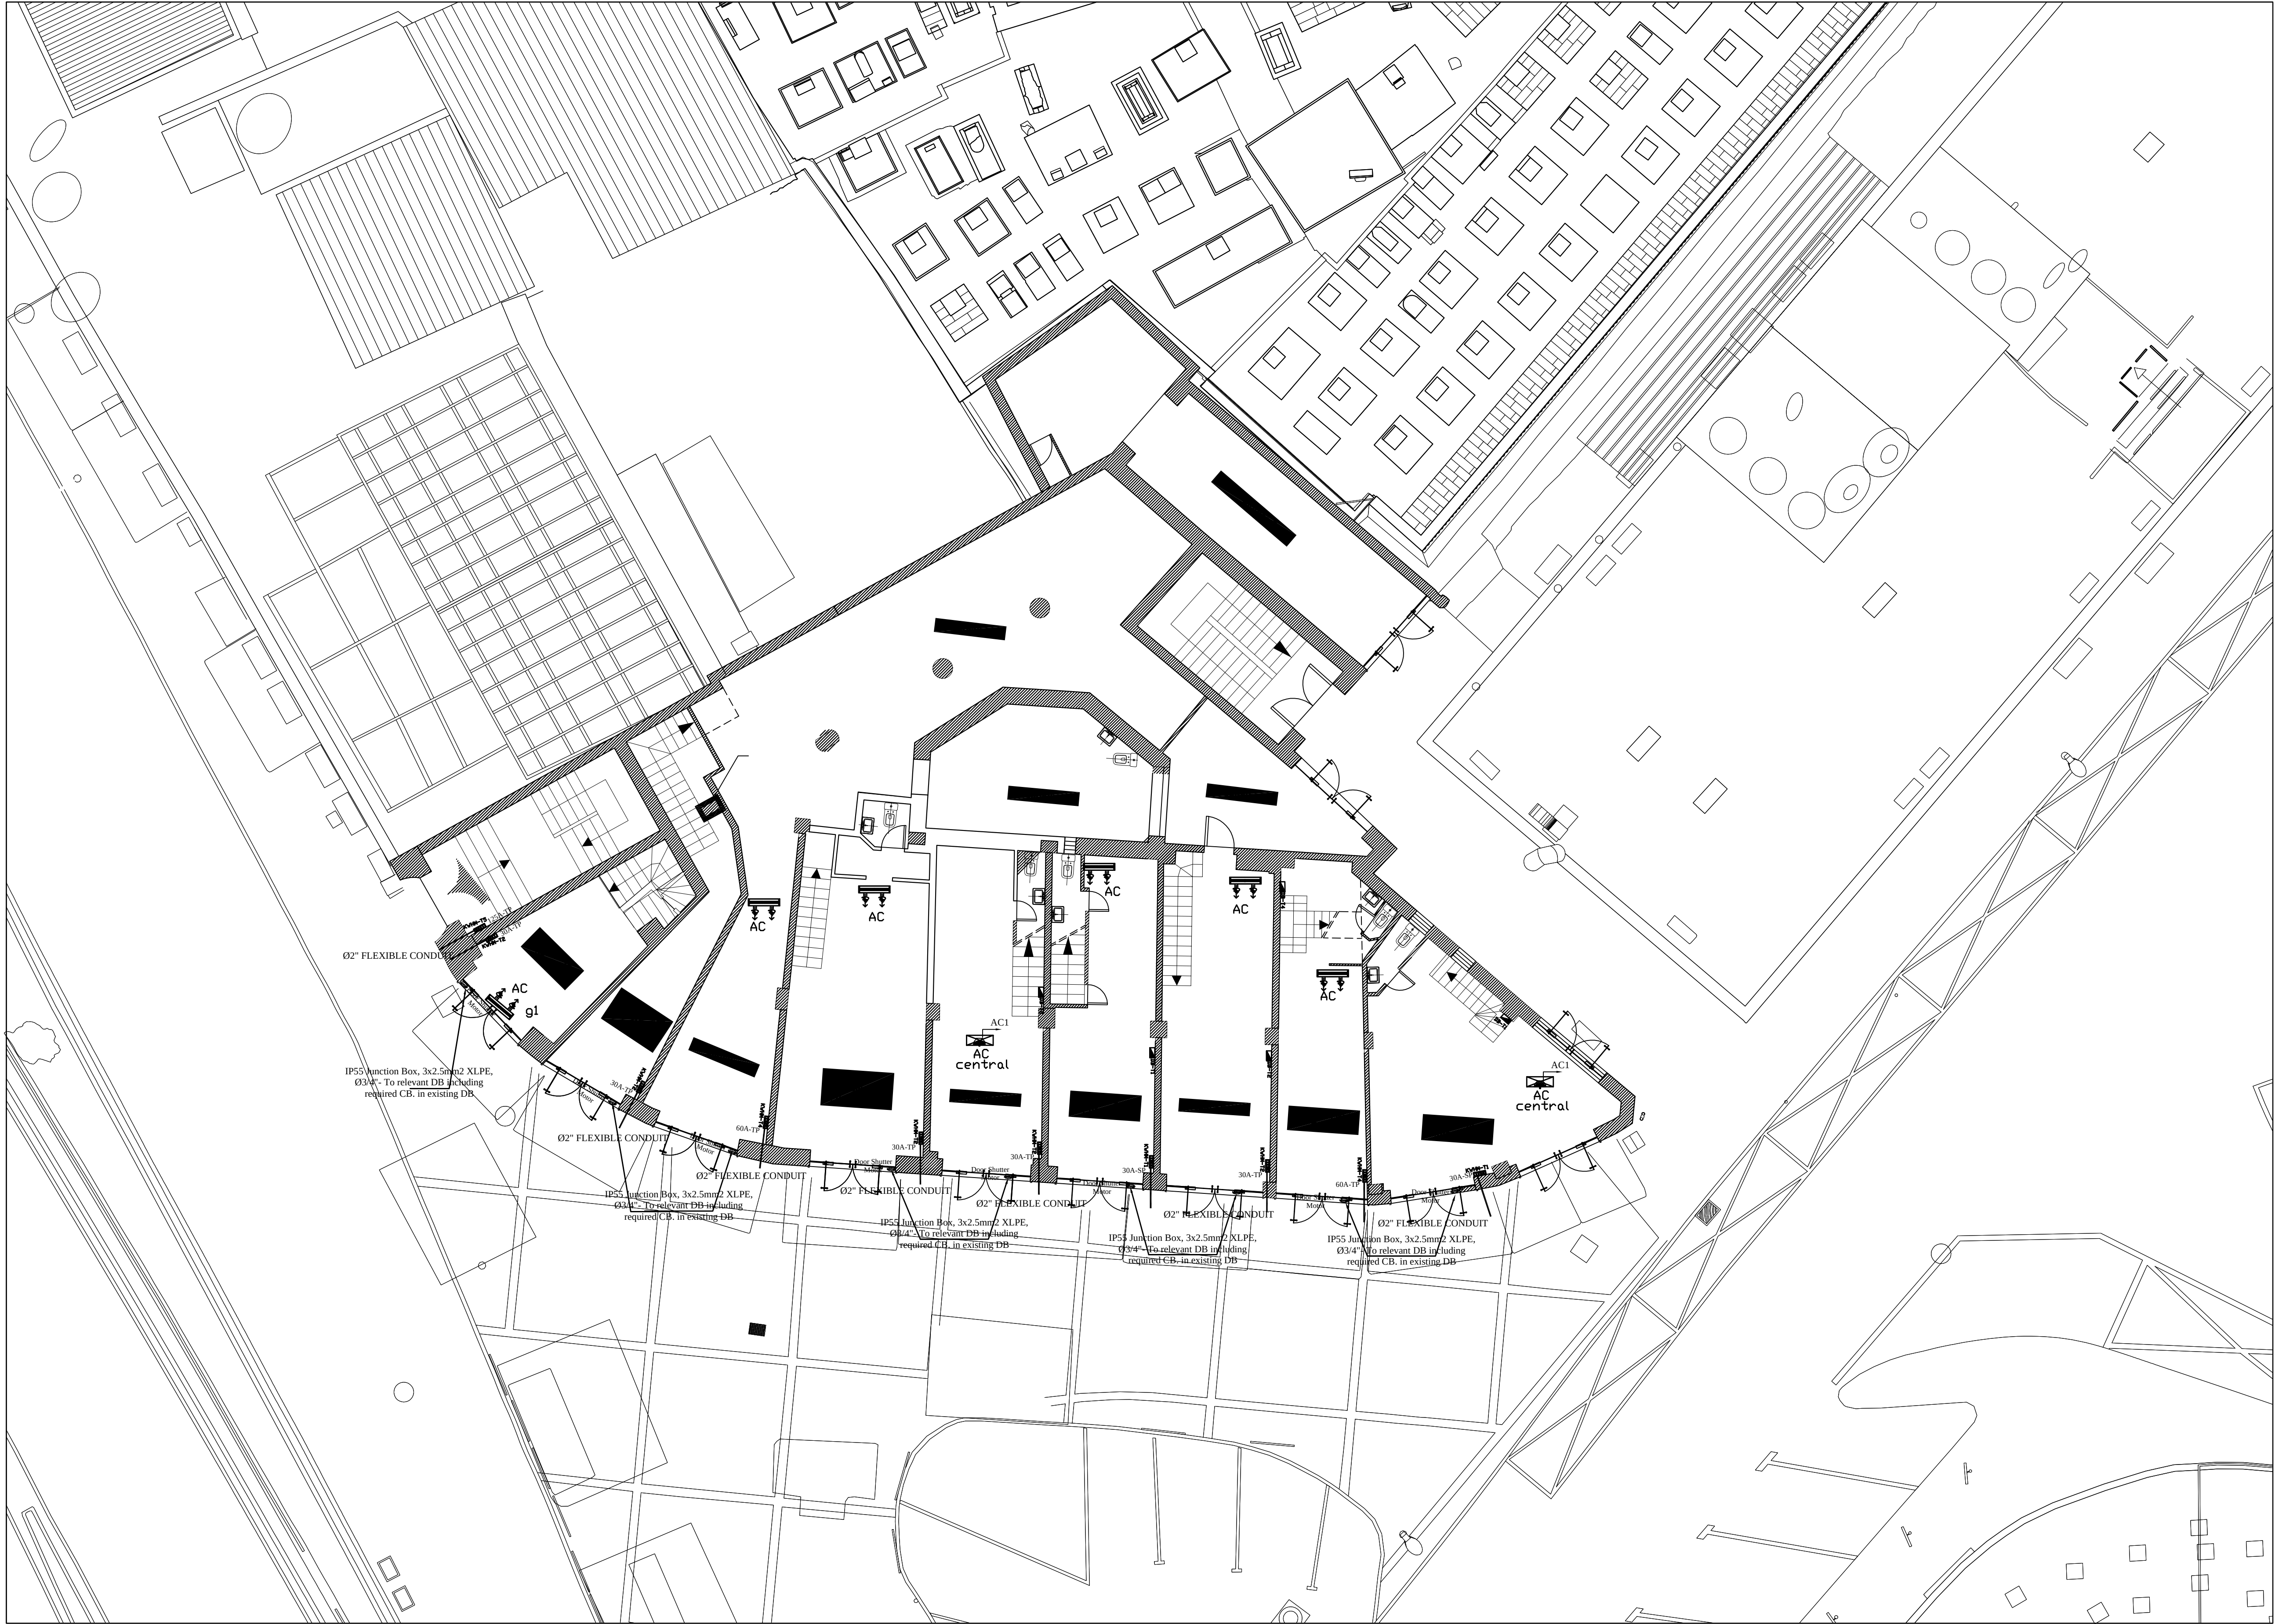

دائرة الأوقاف الإسلامية في القدس

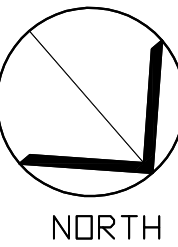

03			
02			
01			
REV	SUBJECT	DATE	BY

NOTES:

LEGEND:

PROJECT TITLE

PRODUCTIVITY& URBAN RENEAL
IN EAST JERUSALEM (PURE)

RENOVATION WORKS OF
BUILDING SS001

SHEET TITLE:


Ground Floor
Power Points Plan

CONSULTANTS:

ZIADAH
ARCHITECTS & ENGINEERS
مهندسون ومهندسون

DOUR
ENGINEERING & PLANNING
CONSULTING ENGINEERS

Scale : 1:1000 When Printed At A4 Sheet	Date : 01/11/2017
Design by : ZIADAH CONSULTANTS	Division : ELECTRICAL
checked by : ZIADAH CONSULTANTS	SHEET NO. E1-01
Drawn by : ZIADAH CONSULTANTS	Project No:1/16

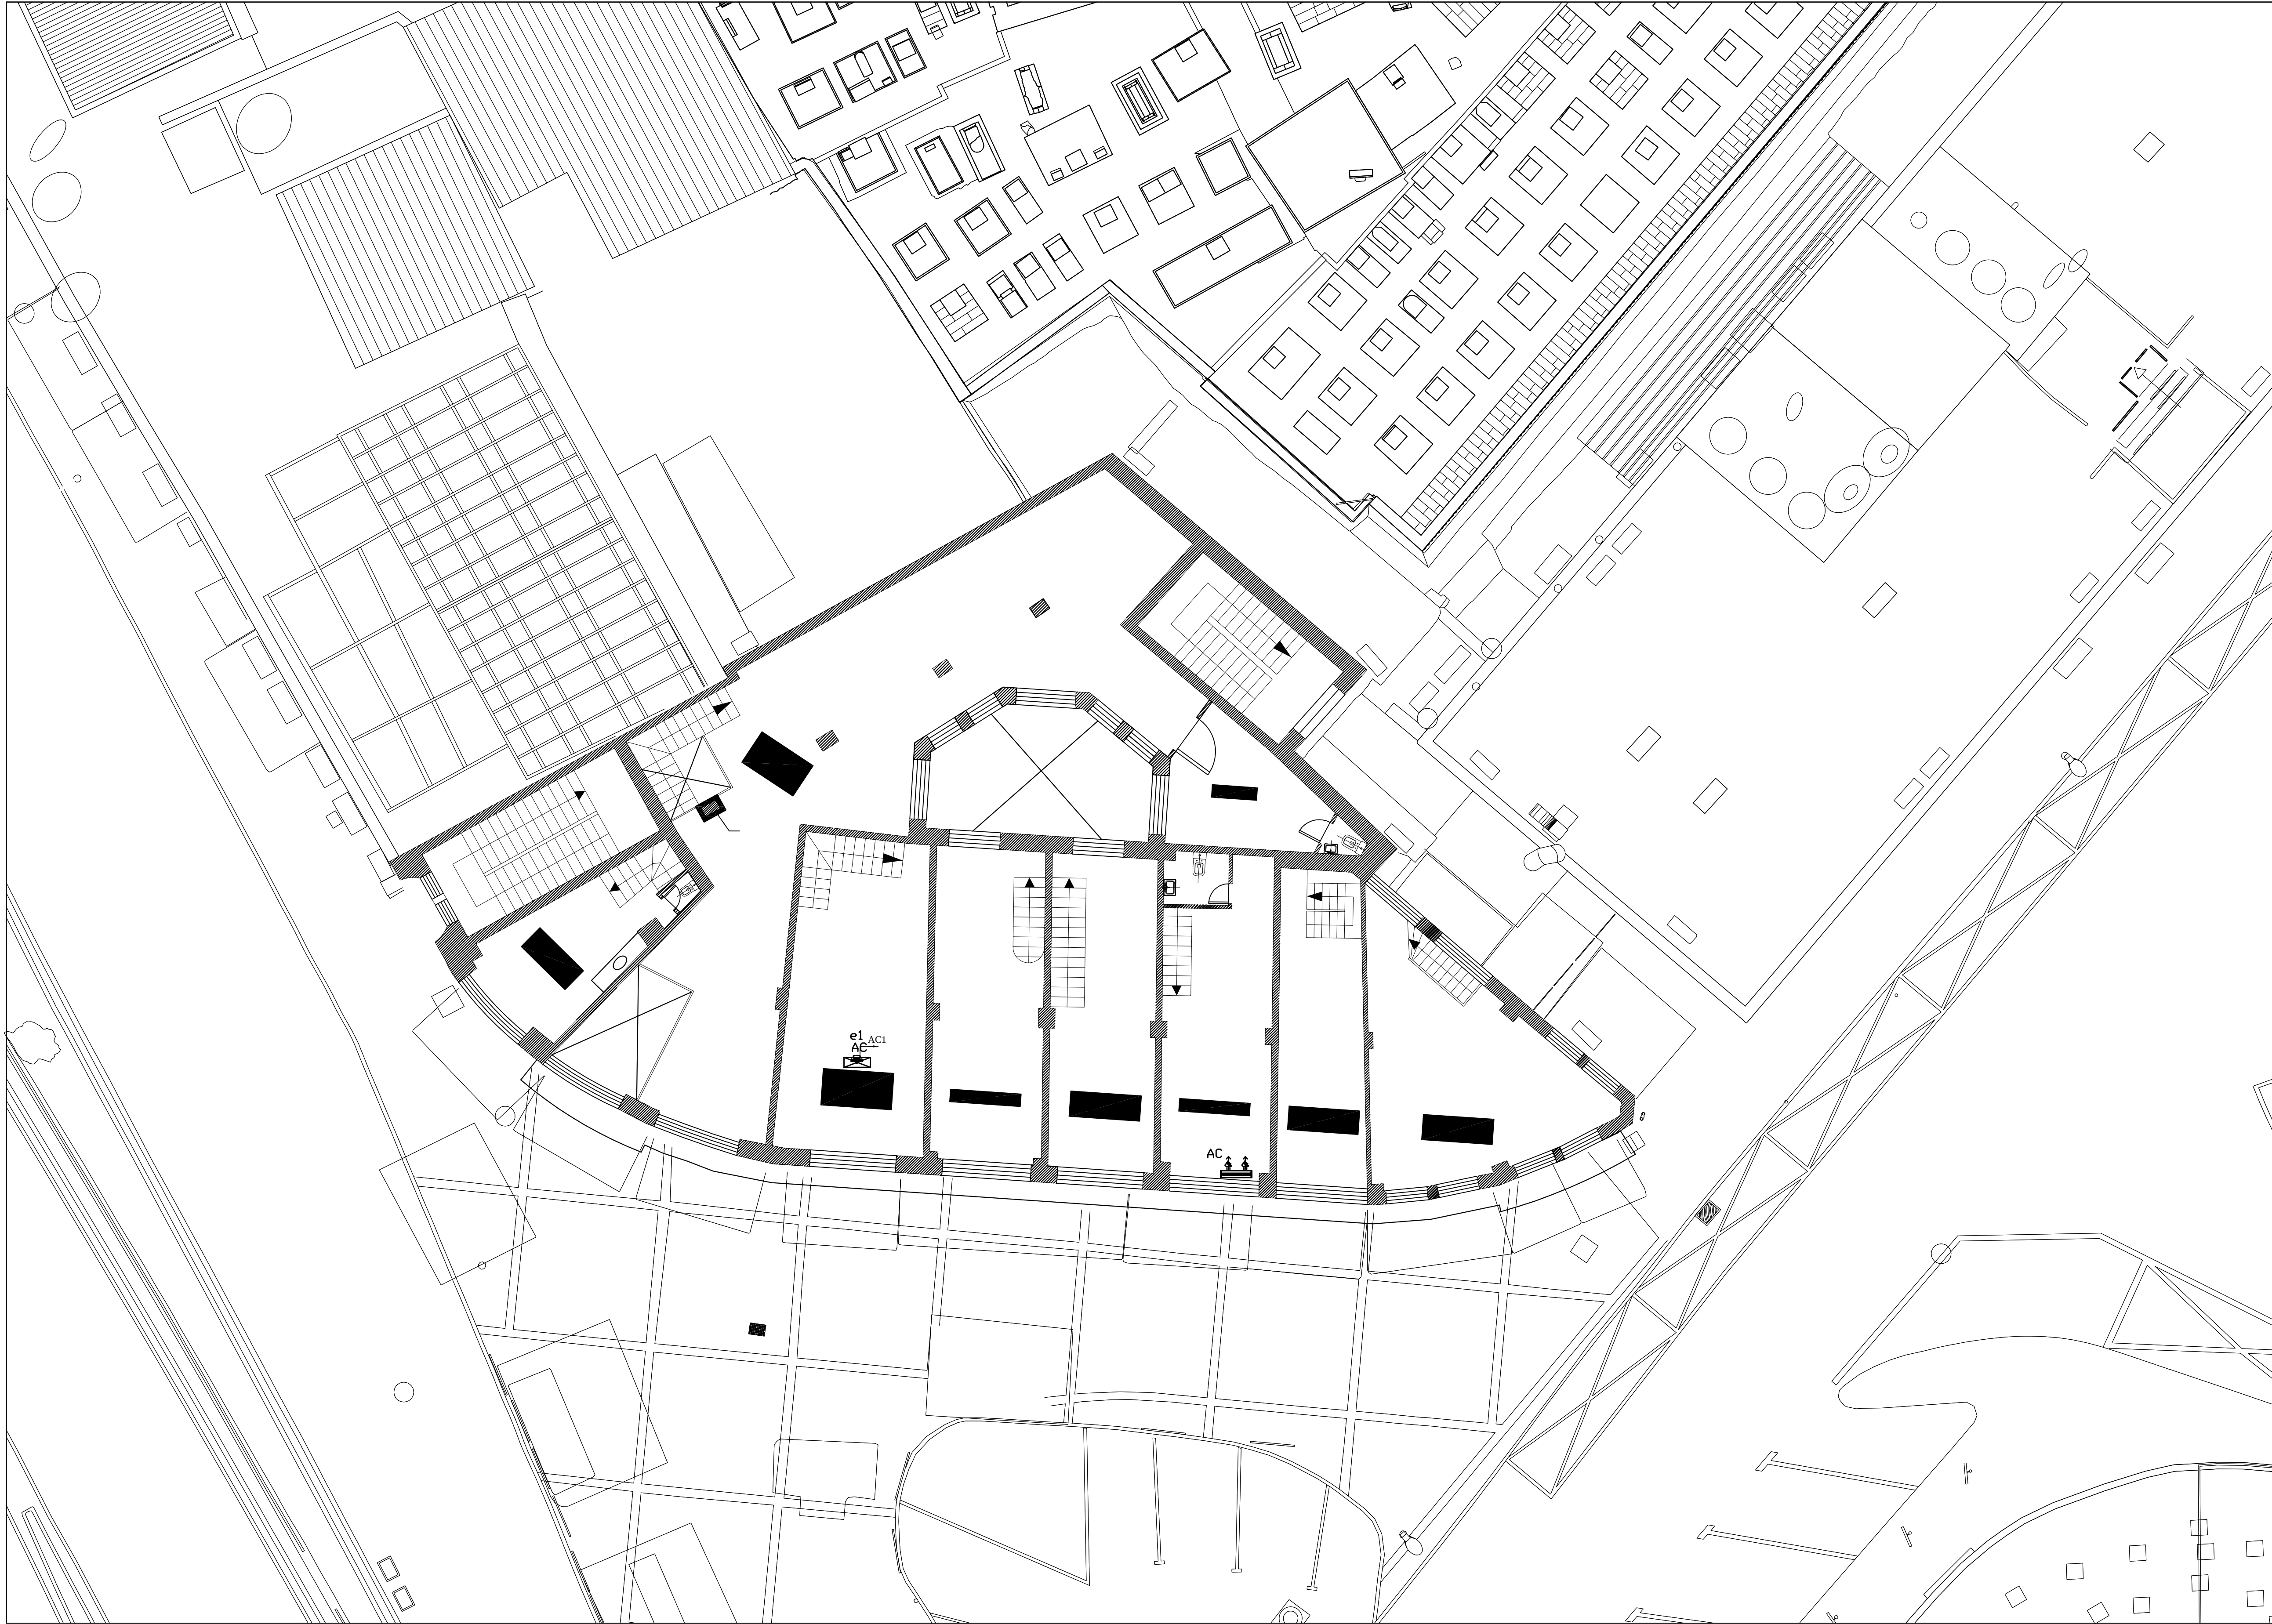


دائرة الأوقاف الإسلامية في القدس



UNDP
United Nations
Development Programme



EUROPEAN UNION

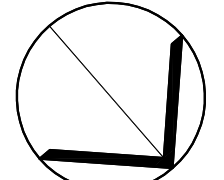

NORTH

03			
02			
01			
REV	SUBJECT	DATE	BY

NOTES:

LEGEND:

PROJECT TITLE

PRODUCTIVITY& URBAN RENEAL
IN EAST JERUSALEM (PURE)

RENOVATION WORKS OF
BUILDING SS001

SHEET TITLE:

Mezzanine Floor
Power Points Plan

CONSULTANTS:




ZIADAH
ARCHITECTS & ENGINEERS
مهندسون ومهندسون




DOUR
ENGINEERING & PLANNING
CONSULTING ENGINEERS

Scale : 1:100 When Printed At A3 Sheet	Date : 01/11/2017
Design by : ZIADAH CONSULTANTS	 centimeters
checked by: ZIADAH CONSULTANTS	Division : ELECTRICAL
Drawn by: ZIADAH CONSULTANTS	SHEET NO. E1-02
Project No:1/16	

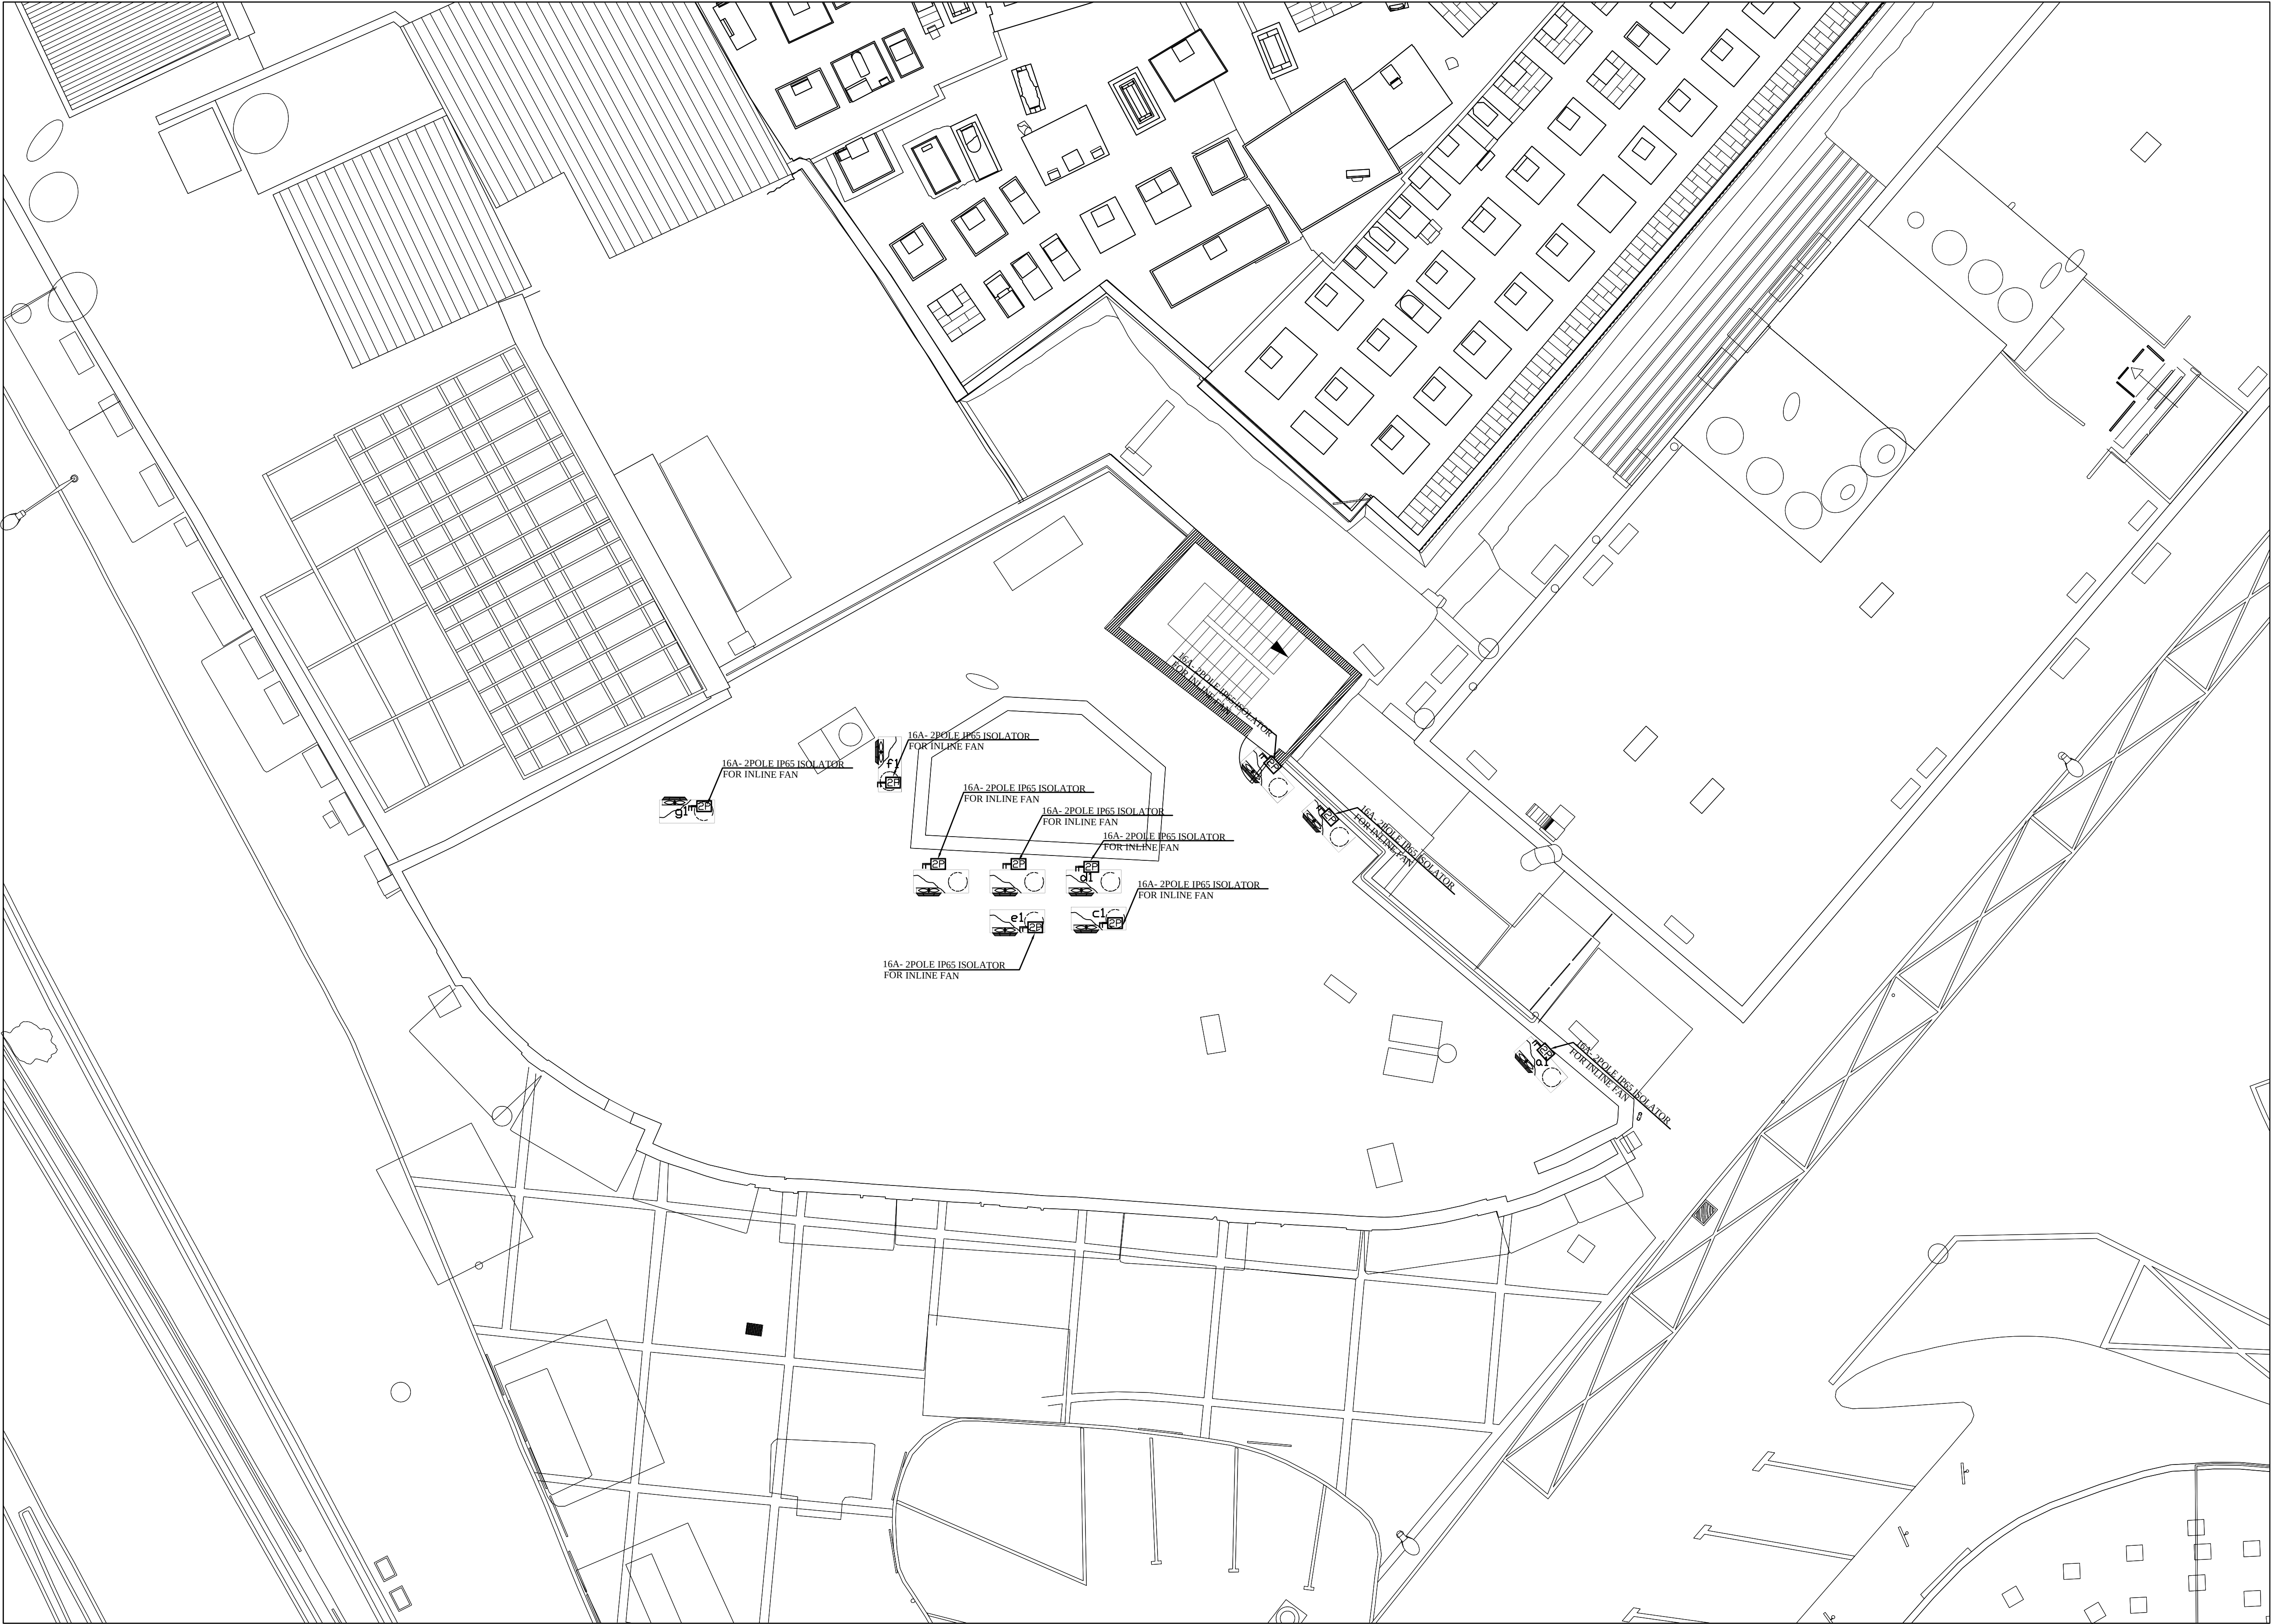

دائرة الأوقاف الإسلامية في القدس

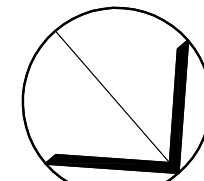

NORTH

03			
02			
01			
REV	SUBJECT	DATE	BY

NOTES:


LEGEND:

PROJECT TITLE
PRODUCTIVITY& URBAN RENEAL
IN EAST JERUSALEM (PURE)
RENOVATION WORKS OF
BUILDING SS001


SHEET TITLE:
**Roof Floor
Power Points Plan**

CONSULTANTS:
ZIADAH
ARCHITECTS & ENGINEERS
مهندسون معماريون ومهندسون
POUR
ENGINEERING & PLANNING
CONSULTING ENGINEERS

Scale : 1:100 When Printed At A3 Sheet	Date : 01/11/2017
Design by : ZIADAH CONSULTANTS	Division : ELECTRICAL
checked by: ZIADAH CONSULTANTS	SHEET NO. E1-03
Drawn by: ZIADAH CONSULTANTS	
Project No:1/16	

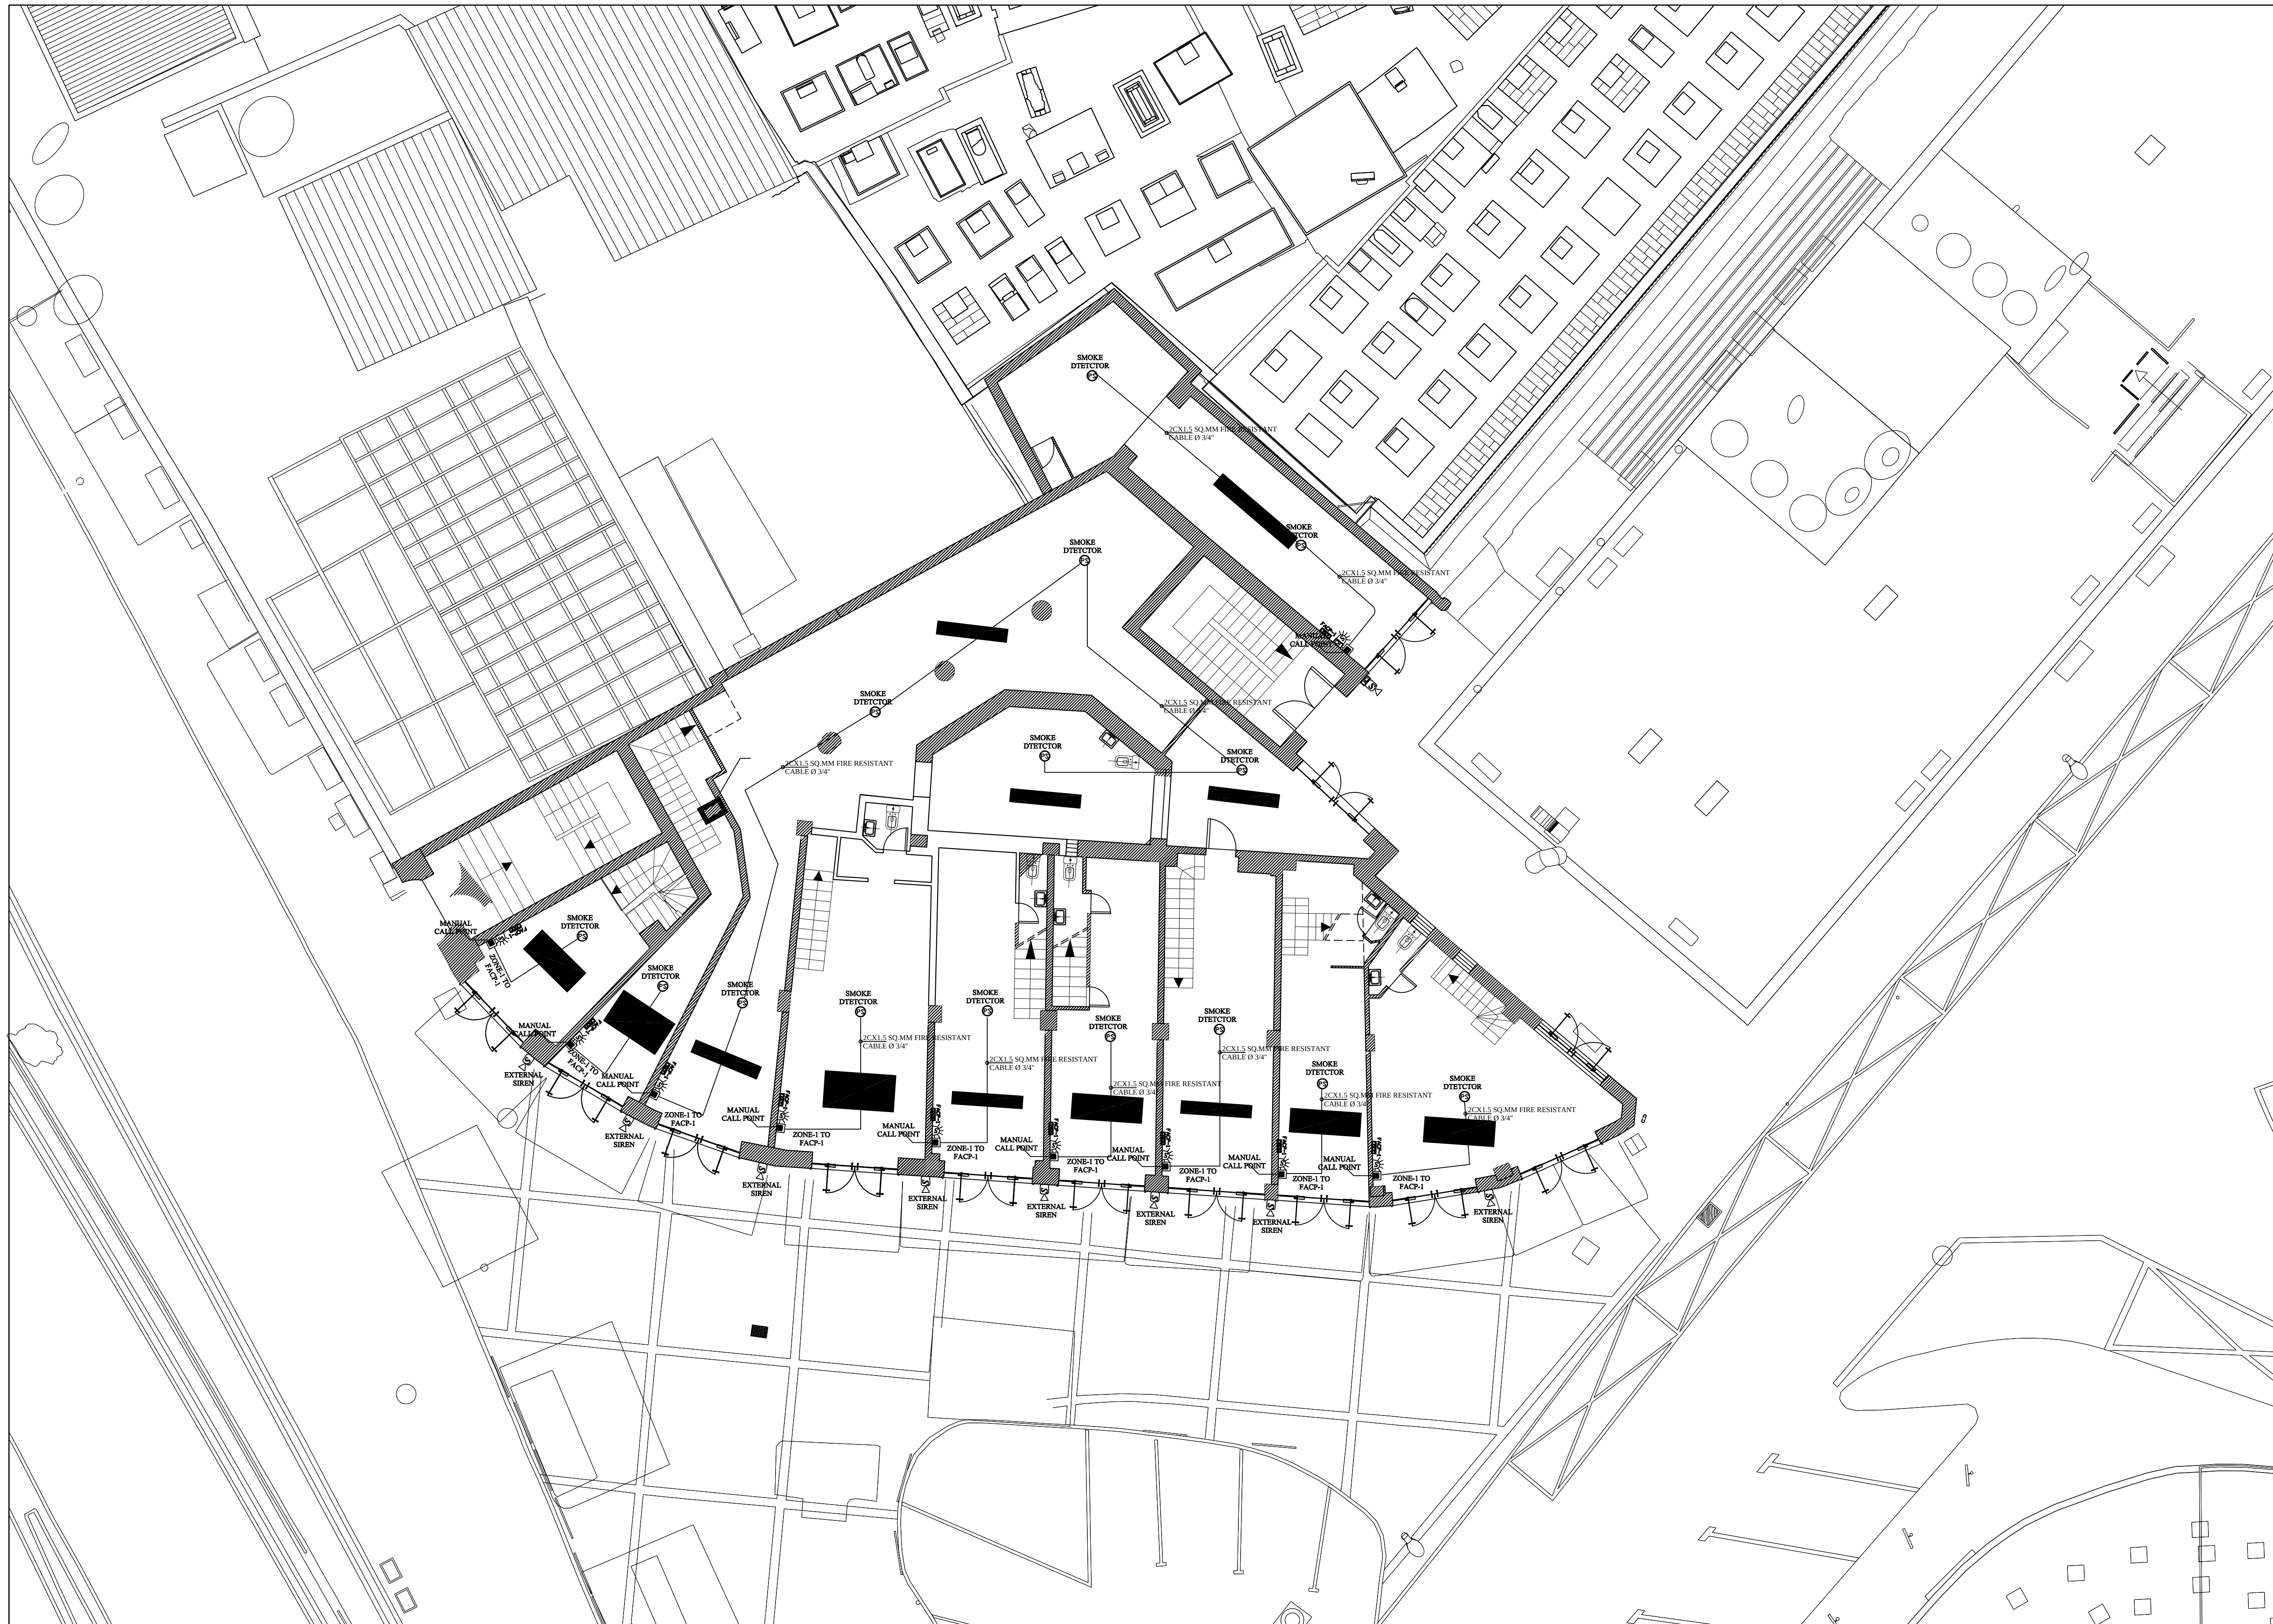

دائرة الأوقاف الإسلامية في القدس

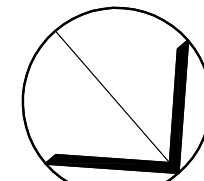

NORTH

03			
02			
01			
REV	SUBJECT	DATE	BY

NOTES:

LEGEND:

PROJECT TITLE

PRODUCTIVITY& URBAN RENEAL
IN EAST JERUSALEM (PURE)
RENOVATION WORKS OF
BUILDING SS001


SHEET TITLE:

Ground Floor
F.A. Points Plan


CONSULTANTS:



Scale : 1:100 When Printed At A4 Sheet	Date : 01/11/2017
Design by : ZIADAH CONSULTANTS	Division : ELECTRICAL
checked by: ZIADAH CONSULTANTS	SHEET NO. E2-01
Drawn by: ZIADAH CONSULTANTS	
Project No:1/16	

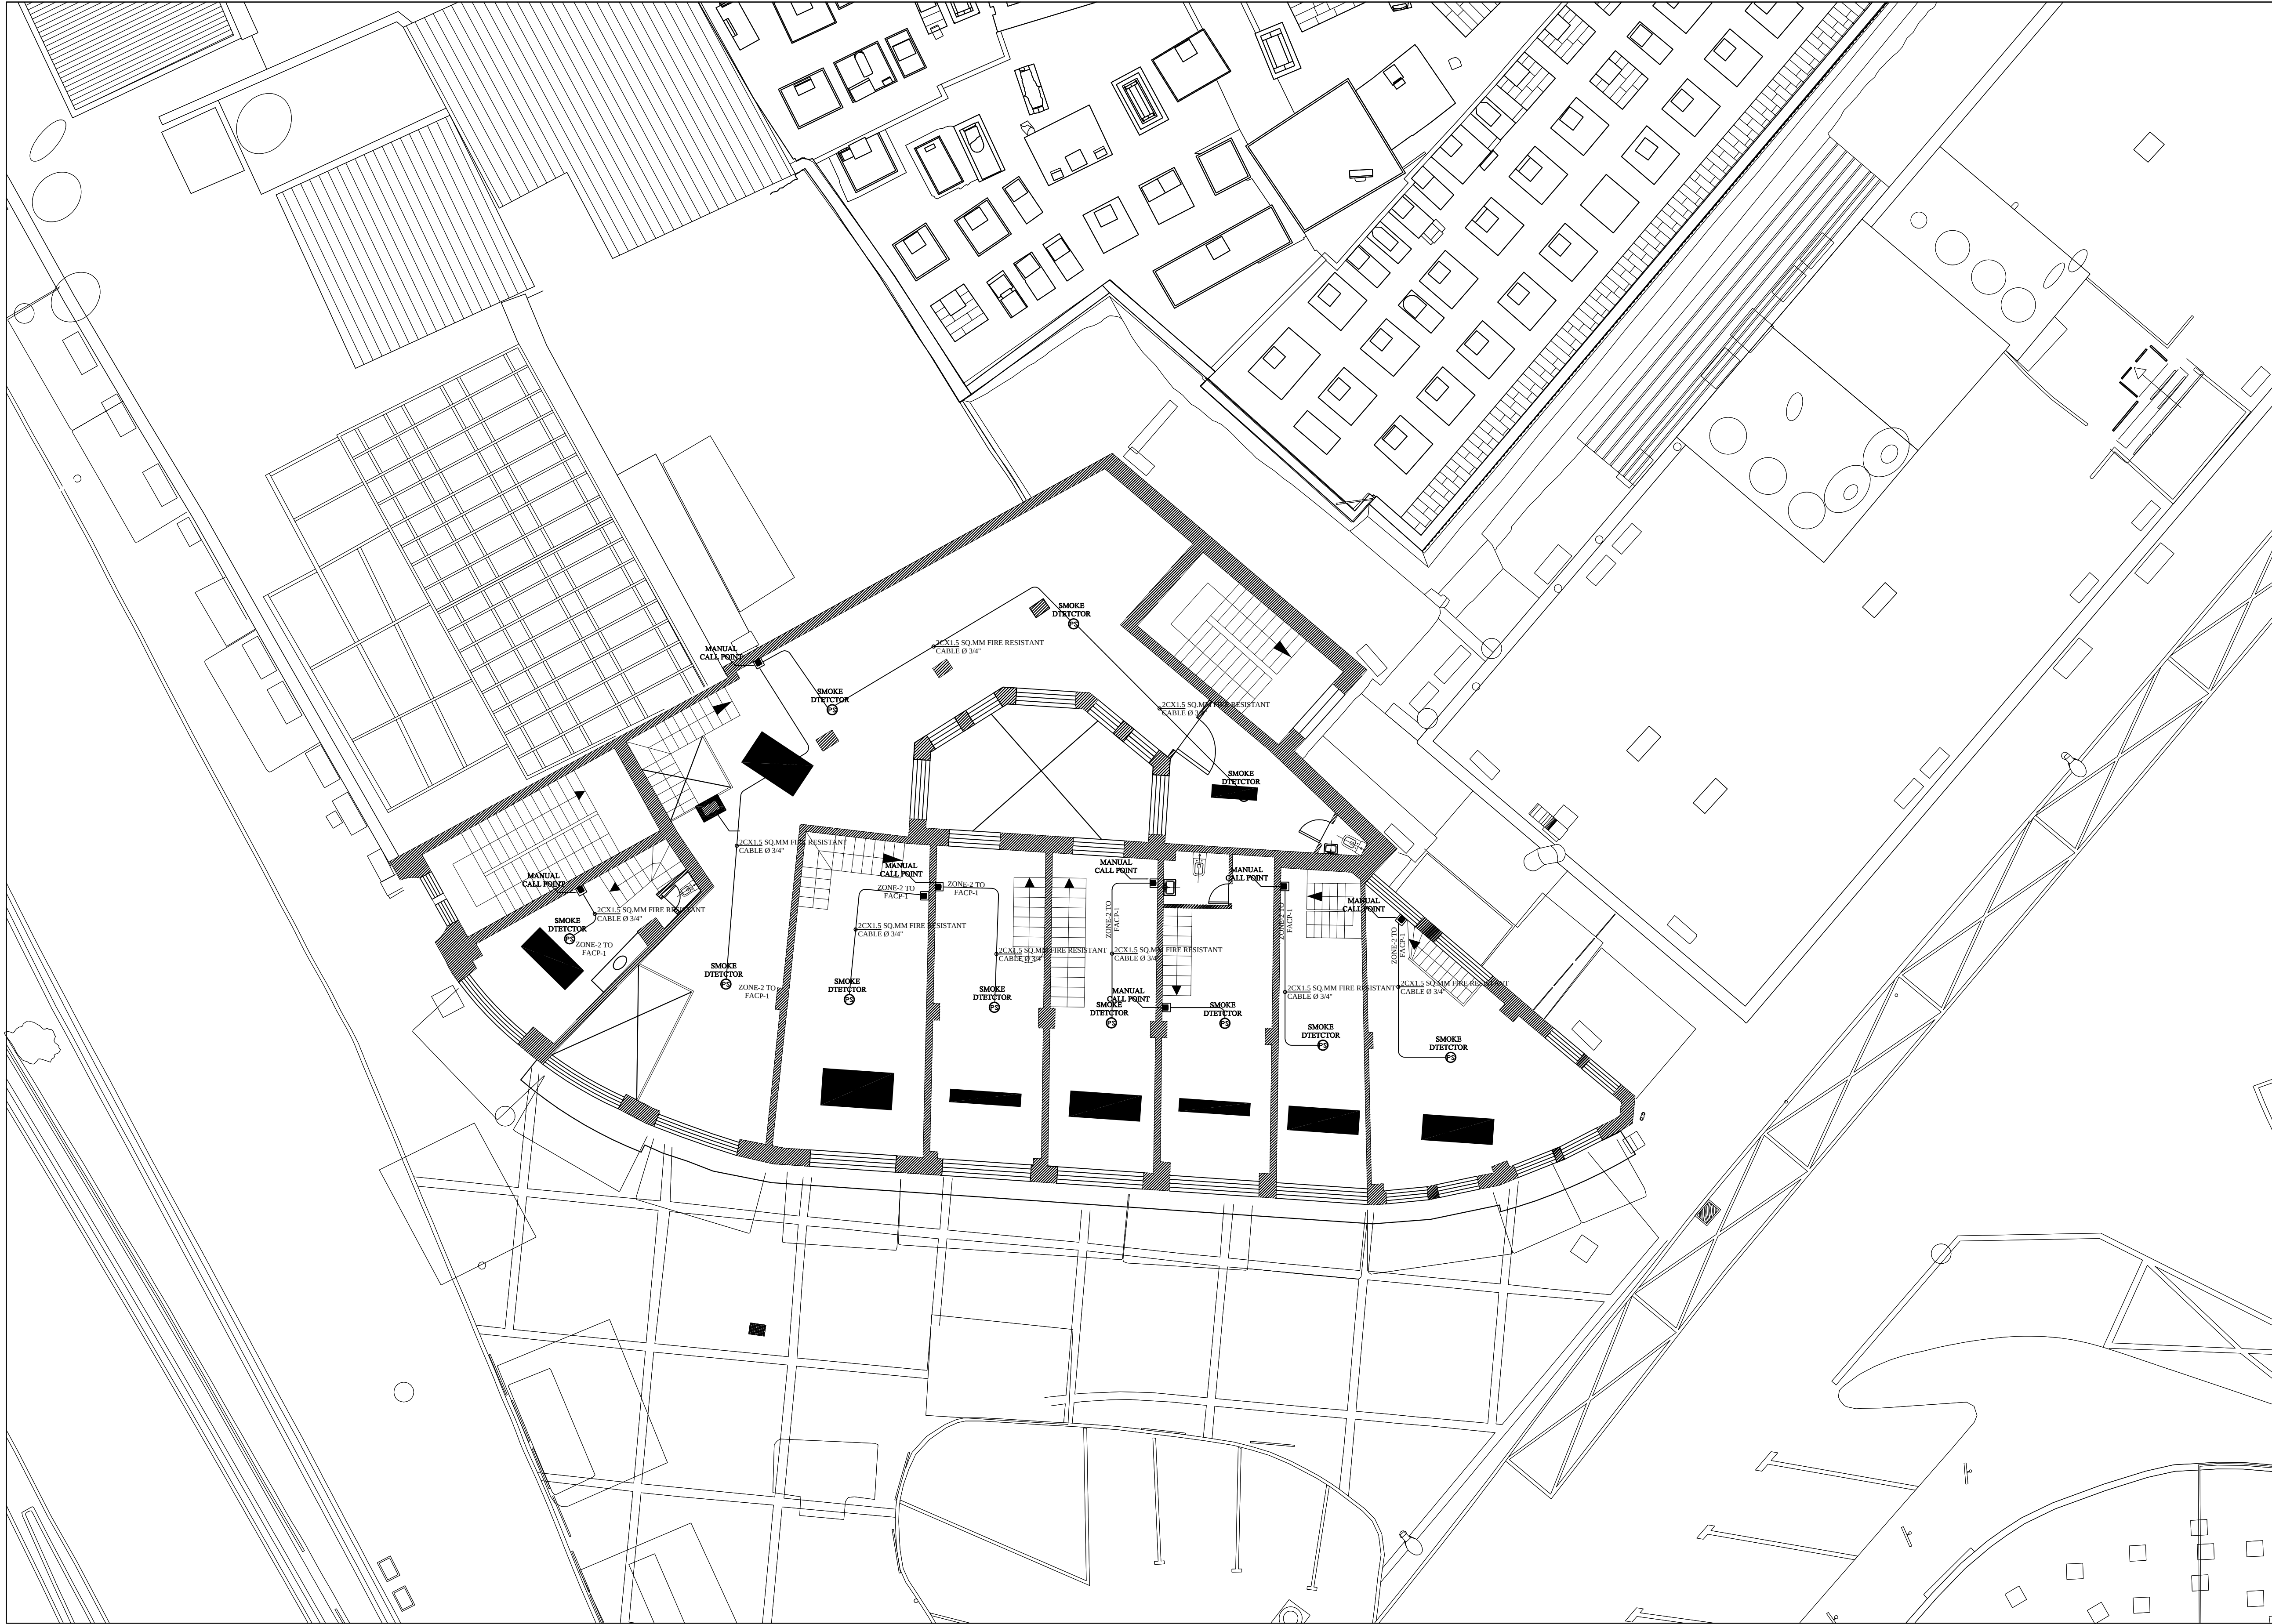

دائرة الأوقاف الإسلامية في القدس

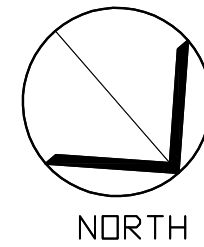

03			
02			
01			
REV	SUBJECT	DATE	BY

NOTES:


LEGEND:

PROJECT TITLE
PRODUCTIVITY& URBAN RENEAL
IN EAST JERUSALEM (PURE)
RENOVATION WORKS OF
BUILDING SS001

SHEET TITLE:
Mezzanine Floor
F.A. Points Plan

CONSULTANTS:
ZIADAH
ARCHITECTS & ENGINEERS
مهندسون وعلماء
DOUR
ENGINEERING & PLANNING
CONSULTING ENGINEERS

Scale : 1:100 When Printed At A3 Sheet	Date : 01/11/2017
Design by : ZIADAH CONSULTANTS	Division : ELECTRICAL
checked by: ZIADAH CONSULTANTS	SHEET NO. E2-02
Drawn by: ZIADAH CONSULTANTS	Project No:1/16

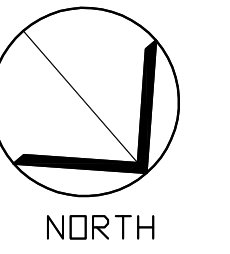

03			
02			
01			
REV.	SUBJECT	DATE	BY

NOTES:

LEGEND:

PROJECT TITLE

PRODUCTIVITY& URBAN RENEWAL
IN EAST JERUSALEM (PURE)
RENOVATION WORKS OF
BUILDING SS001

SHEET TITLE:


First Floor F.A. Points Plan

CONSULTANTS:

ZIA>AH
ARCHITECTS & ENGINEERS
معماران و مهندسان

POUR ENGINEERING & PLANNING
CONSULTING ENGINEERS

Scale : 1:100 When Printed At Sheet	Date : 01/11/2017
Design by : ZIADAH CONSULTANTS	
checked by: ZIADAH CONSULTANTS	Division : ELECTRICAL
Drawn by: ZIADAH CONSULTANTS	SHEET NO. E2-03
Project No:1/16	

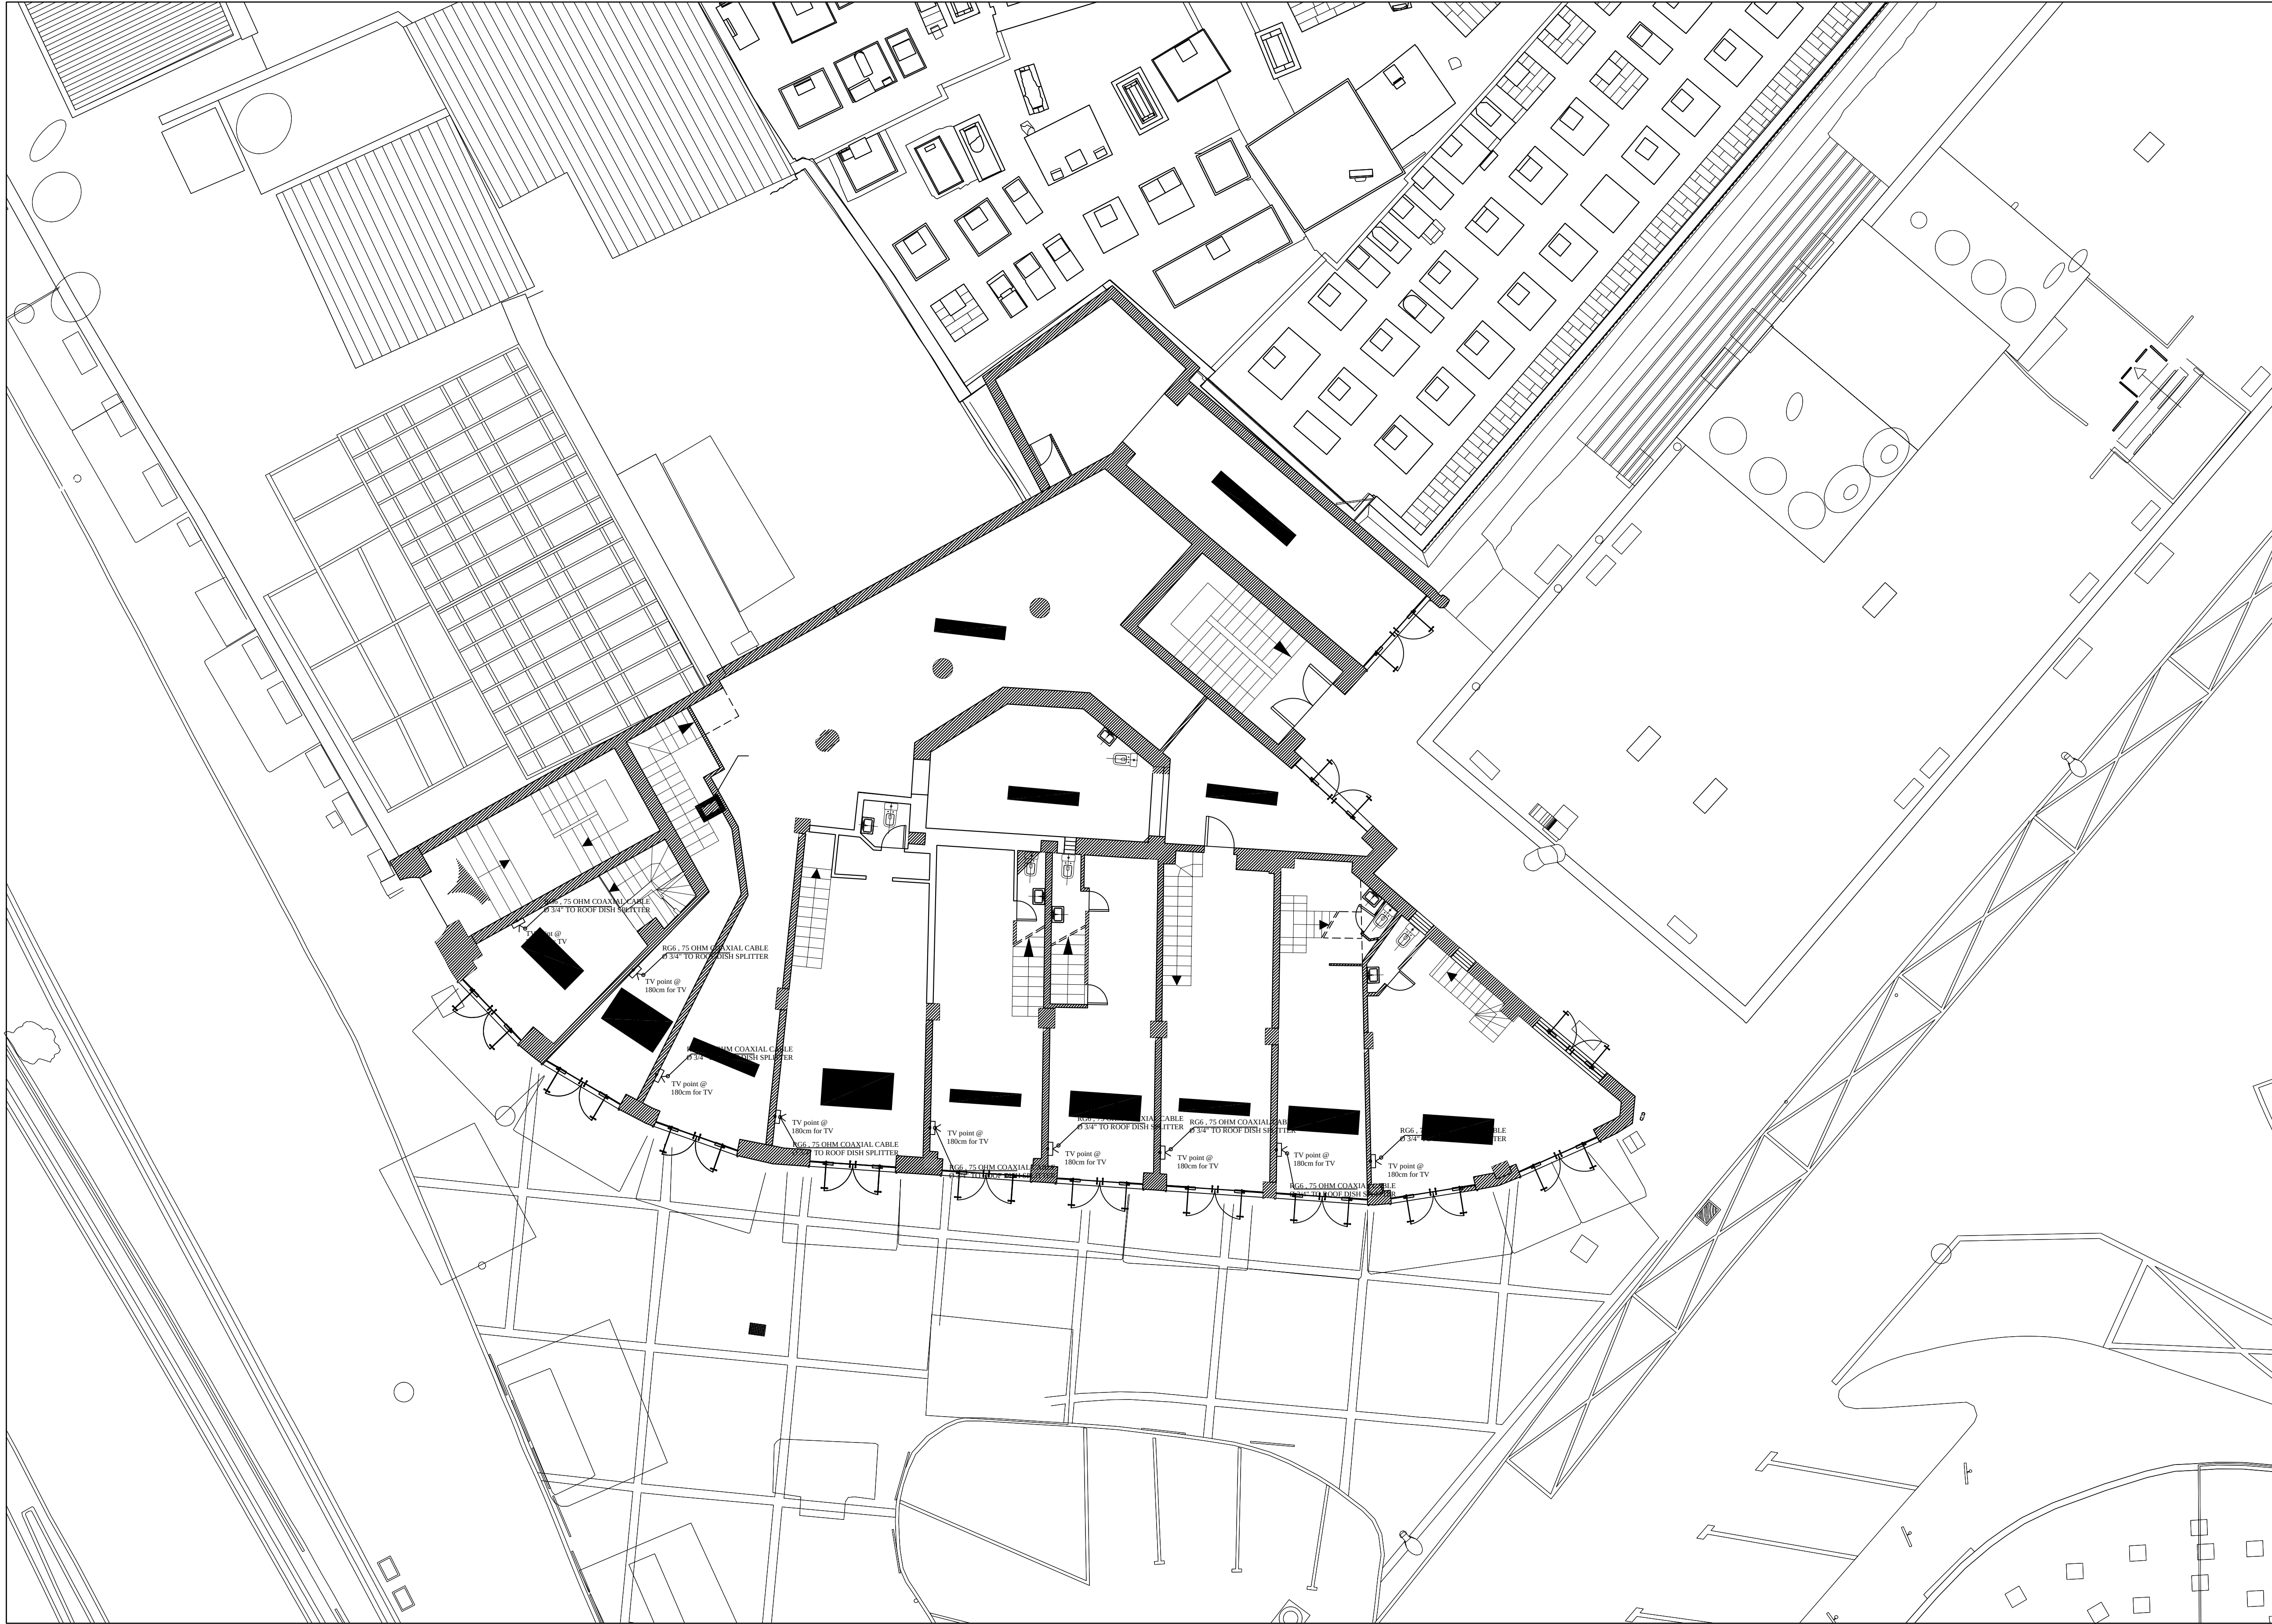


دائرة الأوقاف الإسلامية في القدس



UNDP
United Nations
Development Programme



EUROPEAN UNION

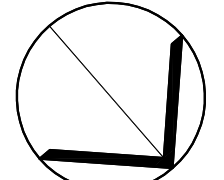

NORTH

03			
02			
01			
REV	SUBJECT	DATE	BY

NOTES:

LEGEND:

PROJECT TITLE

PRODUCTIVITY& URBAN RENEAL
IN EAST JERUSALEM (PURE)

RENOVATION WORKS OF
BUILDING SS001

SHEET TITLE:

Ground Floor
L.V. Points Plan

CONSULTANTS:




ZIADAH
ARCHITECTS & ENGINEERS
مهندسون وعلماء




DOUR
ENGINEERING & PLANNING
CONSULTING ENGINEERS

Scale : 1:100 When Printed At 60cm x 90cm	Date : 01/11/2017
Design by : ZIADAH CONSULTANTS	Division : ELECTRICAL
checked by: ZIADAH CONSULTANTS	SHEET NO. E3-01
Drawn by: ZIADAH CONSULTANTS	
Project No:1/16	

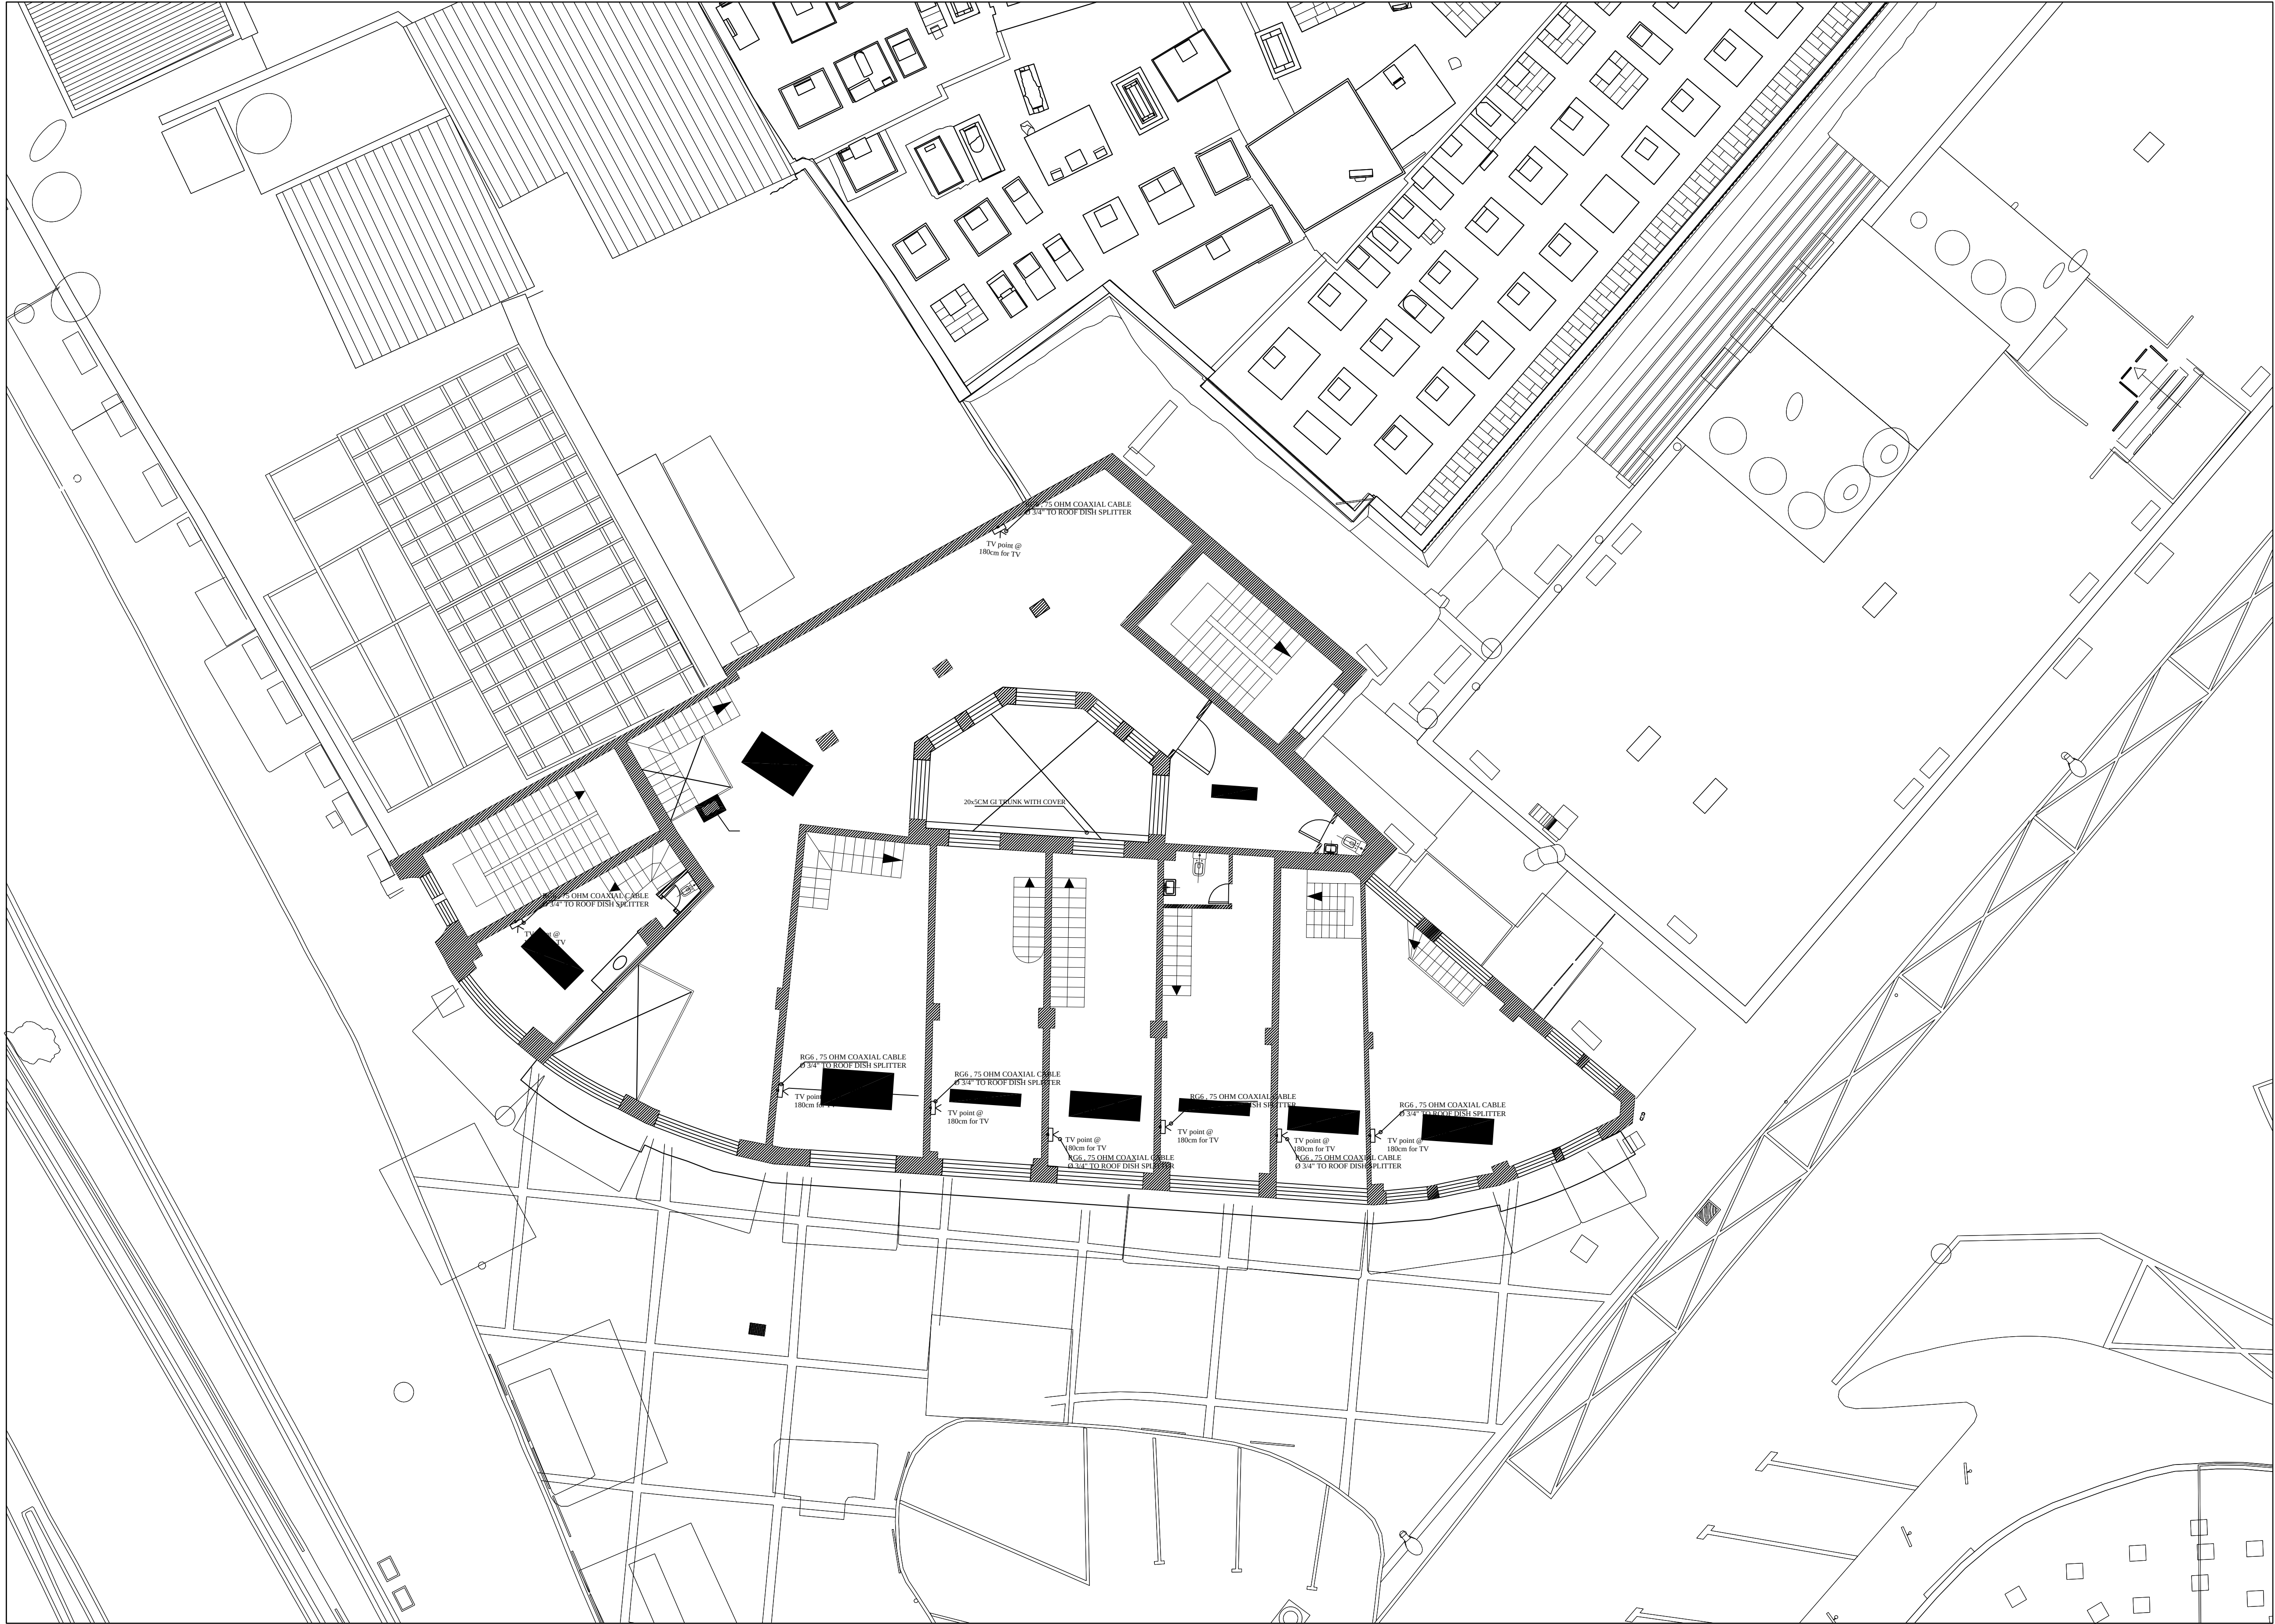

دائرة الأوقاف الإسلامية في القدس

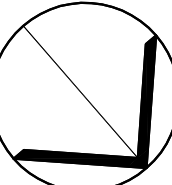

NORTH

03			
02			
01			
REV	SUBJECT	DATE	BY

NOTES:

LEGEND:

PROJECT TITLE


PRODUCTIVITY& URBAN RENEAL
IN EAST JERUSALEM (PURE)

RENOVATION WORKS OF
BUILDING SS001


SHEET TITLE:

Mezzanine Floor
L.V. Points Plan

CONSULTANTS:

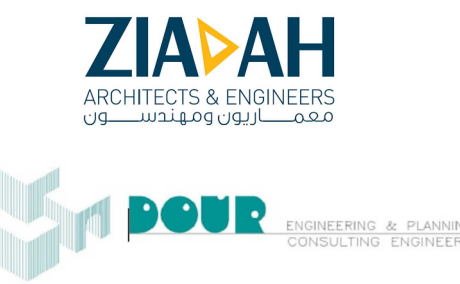

Scale : 1:100 When Printed At A4 Sheet	Date : 01/11/2017
Design by : ZIADAH CONSULTANTS	Division : ELECTRICAL
checked by: ZIADAH CONSULTANTS	SHEET NO. E3-02
Drawn by: ZIADAH CONSULTANTS	Project No:1/16

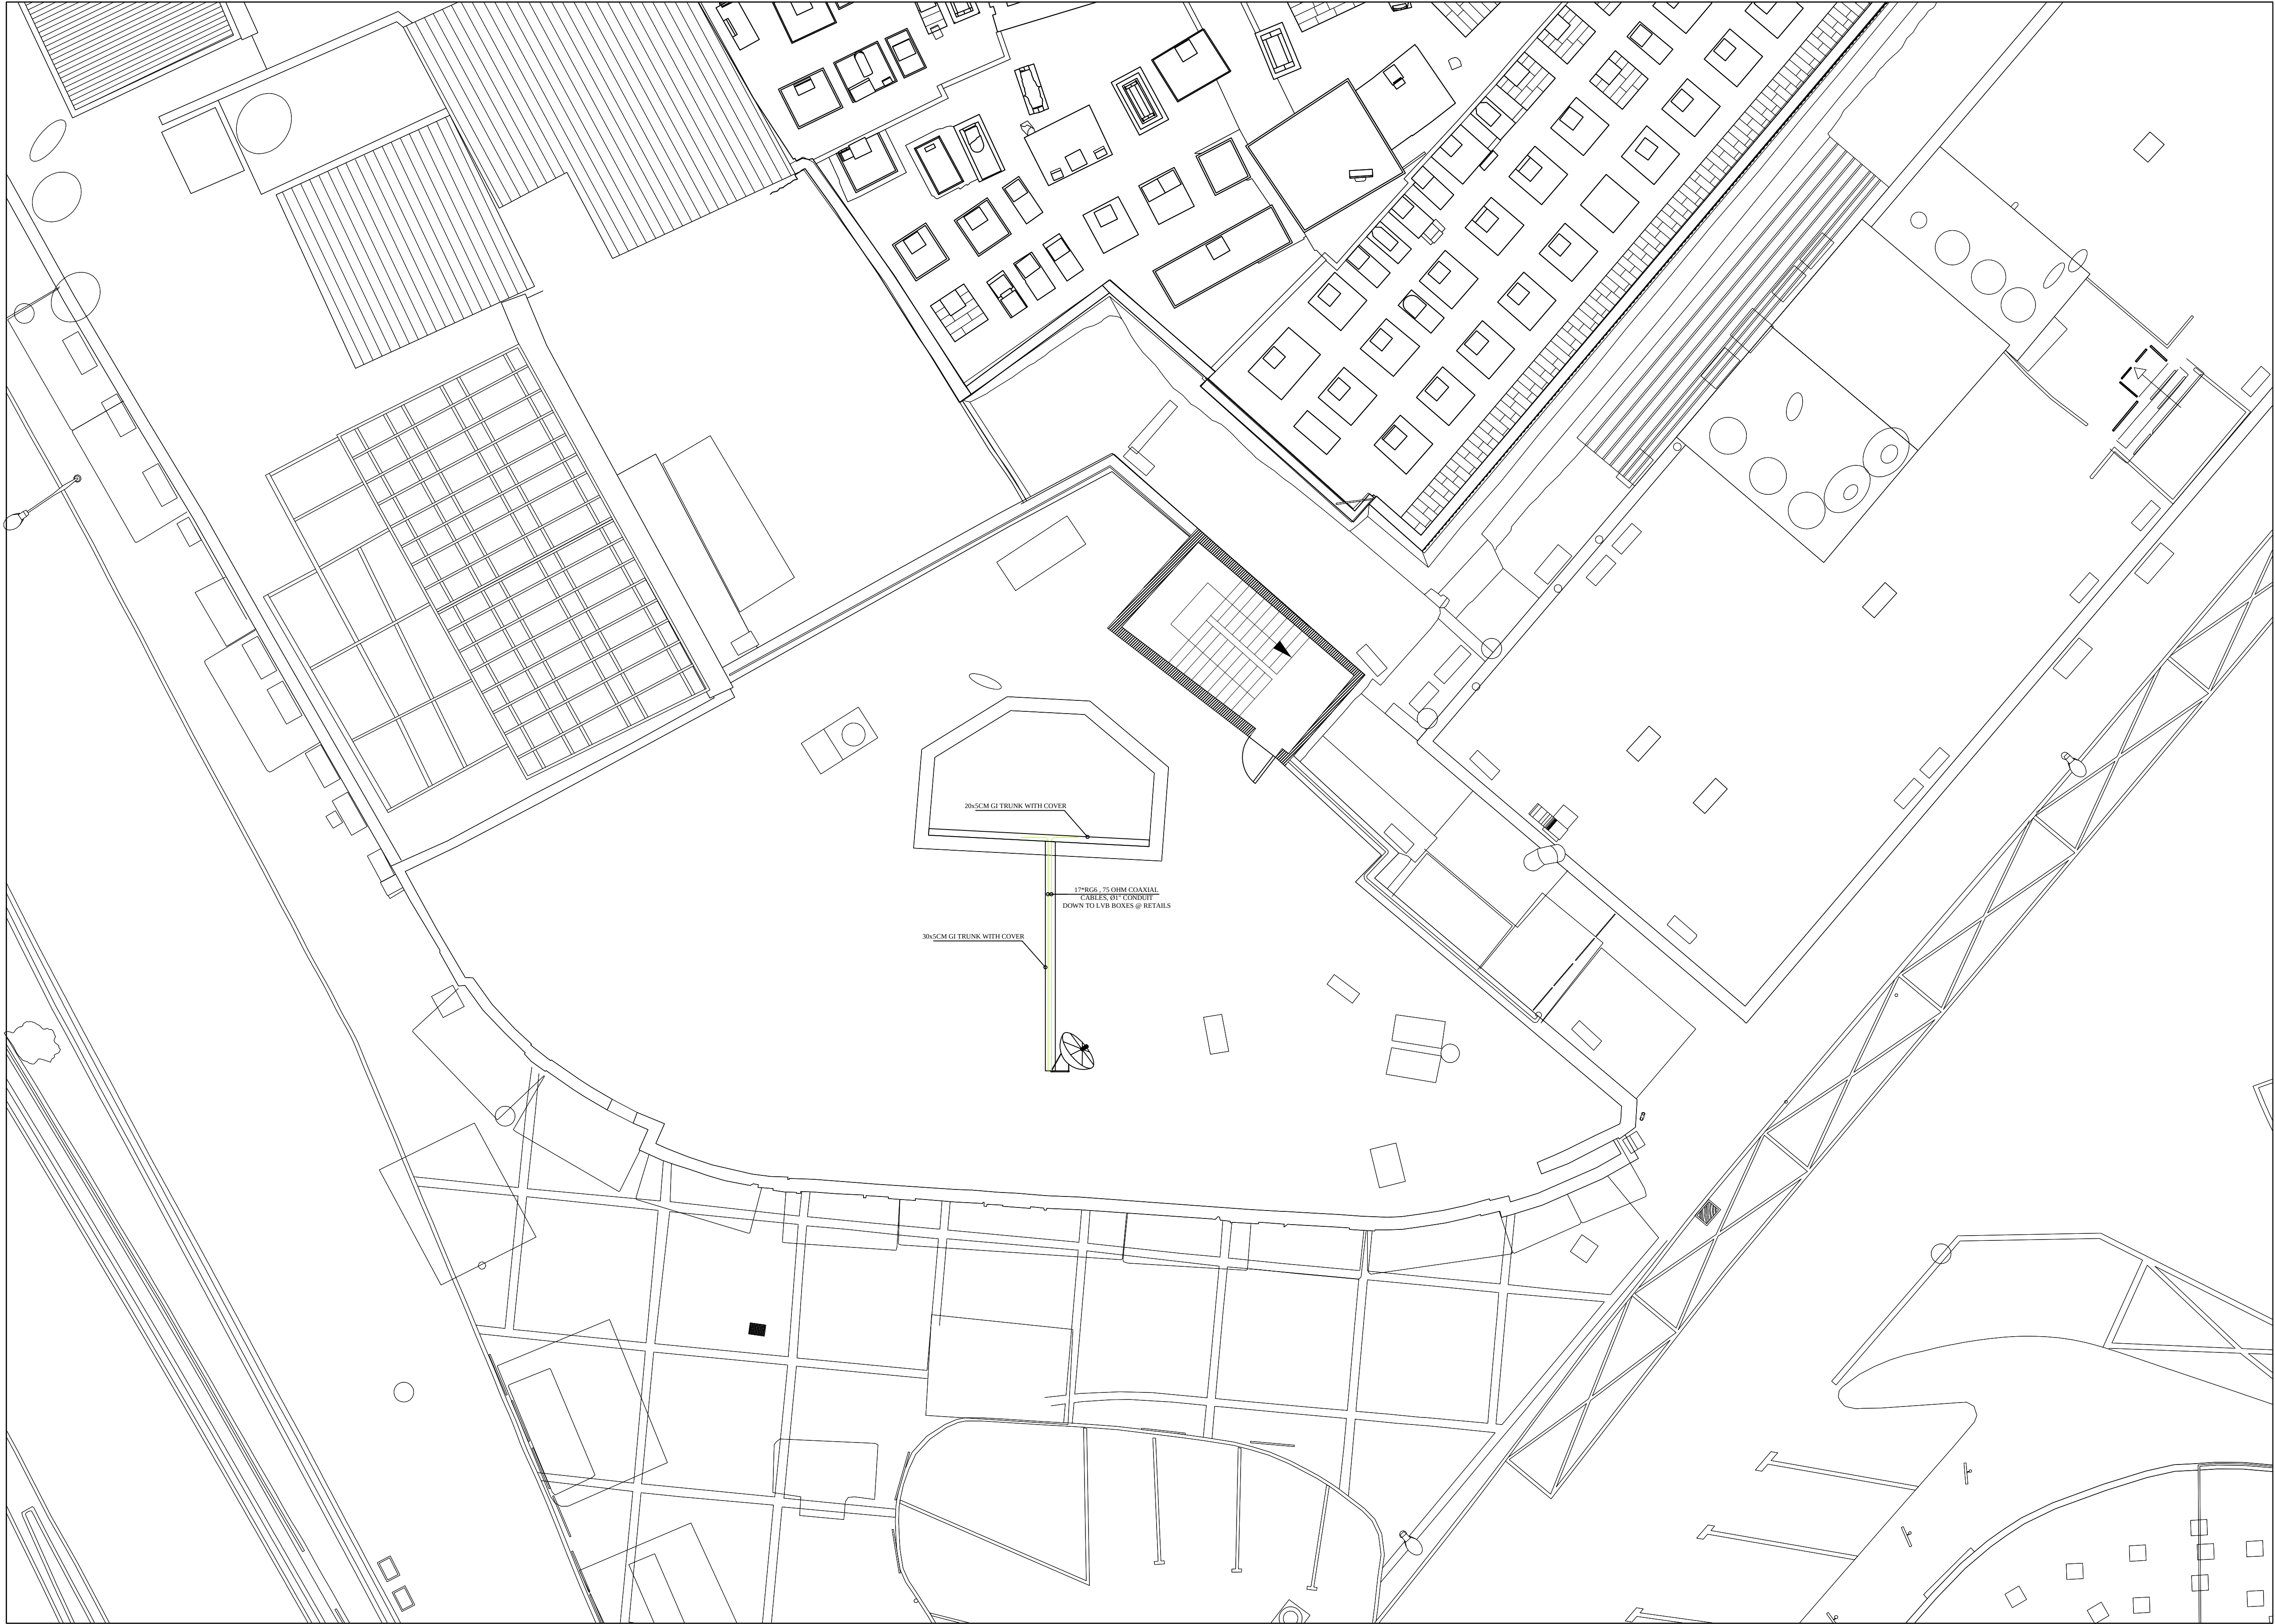

دائرة الأوقاف الإسلامية في القدس

هذا المشروع يدعمه من

UNDP
United Nations
Development Programme

EUROPEAN UNION

03			
02			
01			
REV	SUBJECT	DATE	BY

NOTES:

LEGEND:

PROJECT TITLE

PRODUCTIVITY& URBAN RENEAL
IN EAST JERUSALEM (PURE)

RENOVATION WORKS OF
BUILDING SS001

SHEET TITLE:


Roof Floor
L.V. Points Plan

CONSULTANTS:

ZIADAH
ARCHITECTS & ENGINEERS
مهندسون ومهندسون

DOUR
ENGINEERING & PLANNING
CONSULTING ENGINEERS

Scale : 1:100 When Printed At A3 Sheet	Date : 01/11/2017
Design by : ZIADAH CONSULTANTS	Division : ELECTRICAL
checked by: ZIADAH CONSULTANTS	SHEET NO. E3-03
Drawn by: ZIADAH CONSULTANTS	
Project No:1/16	

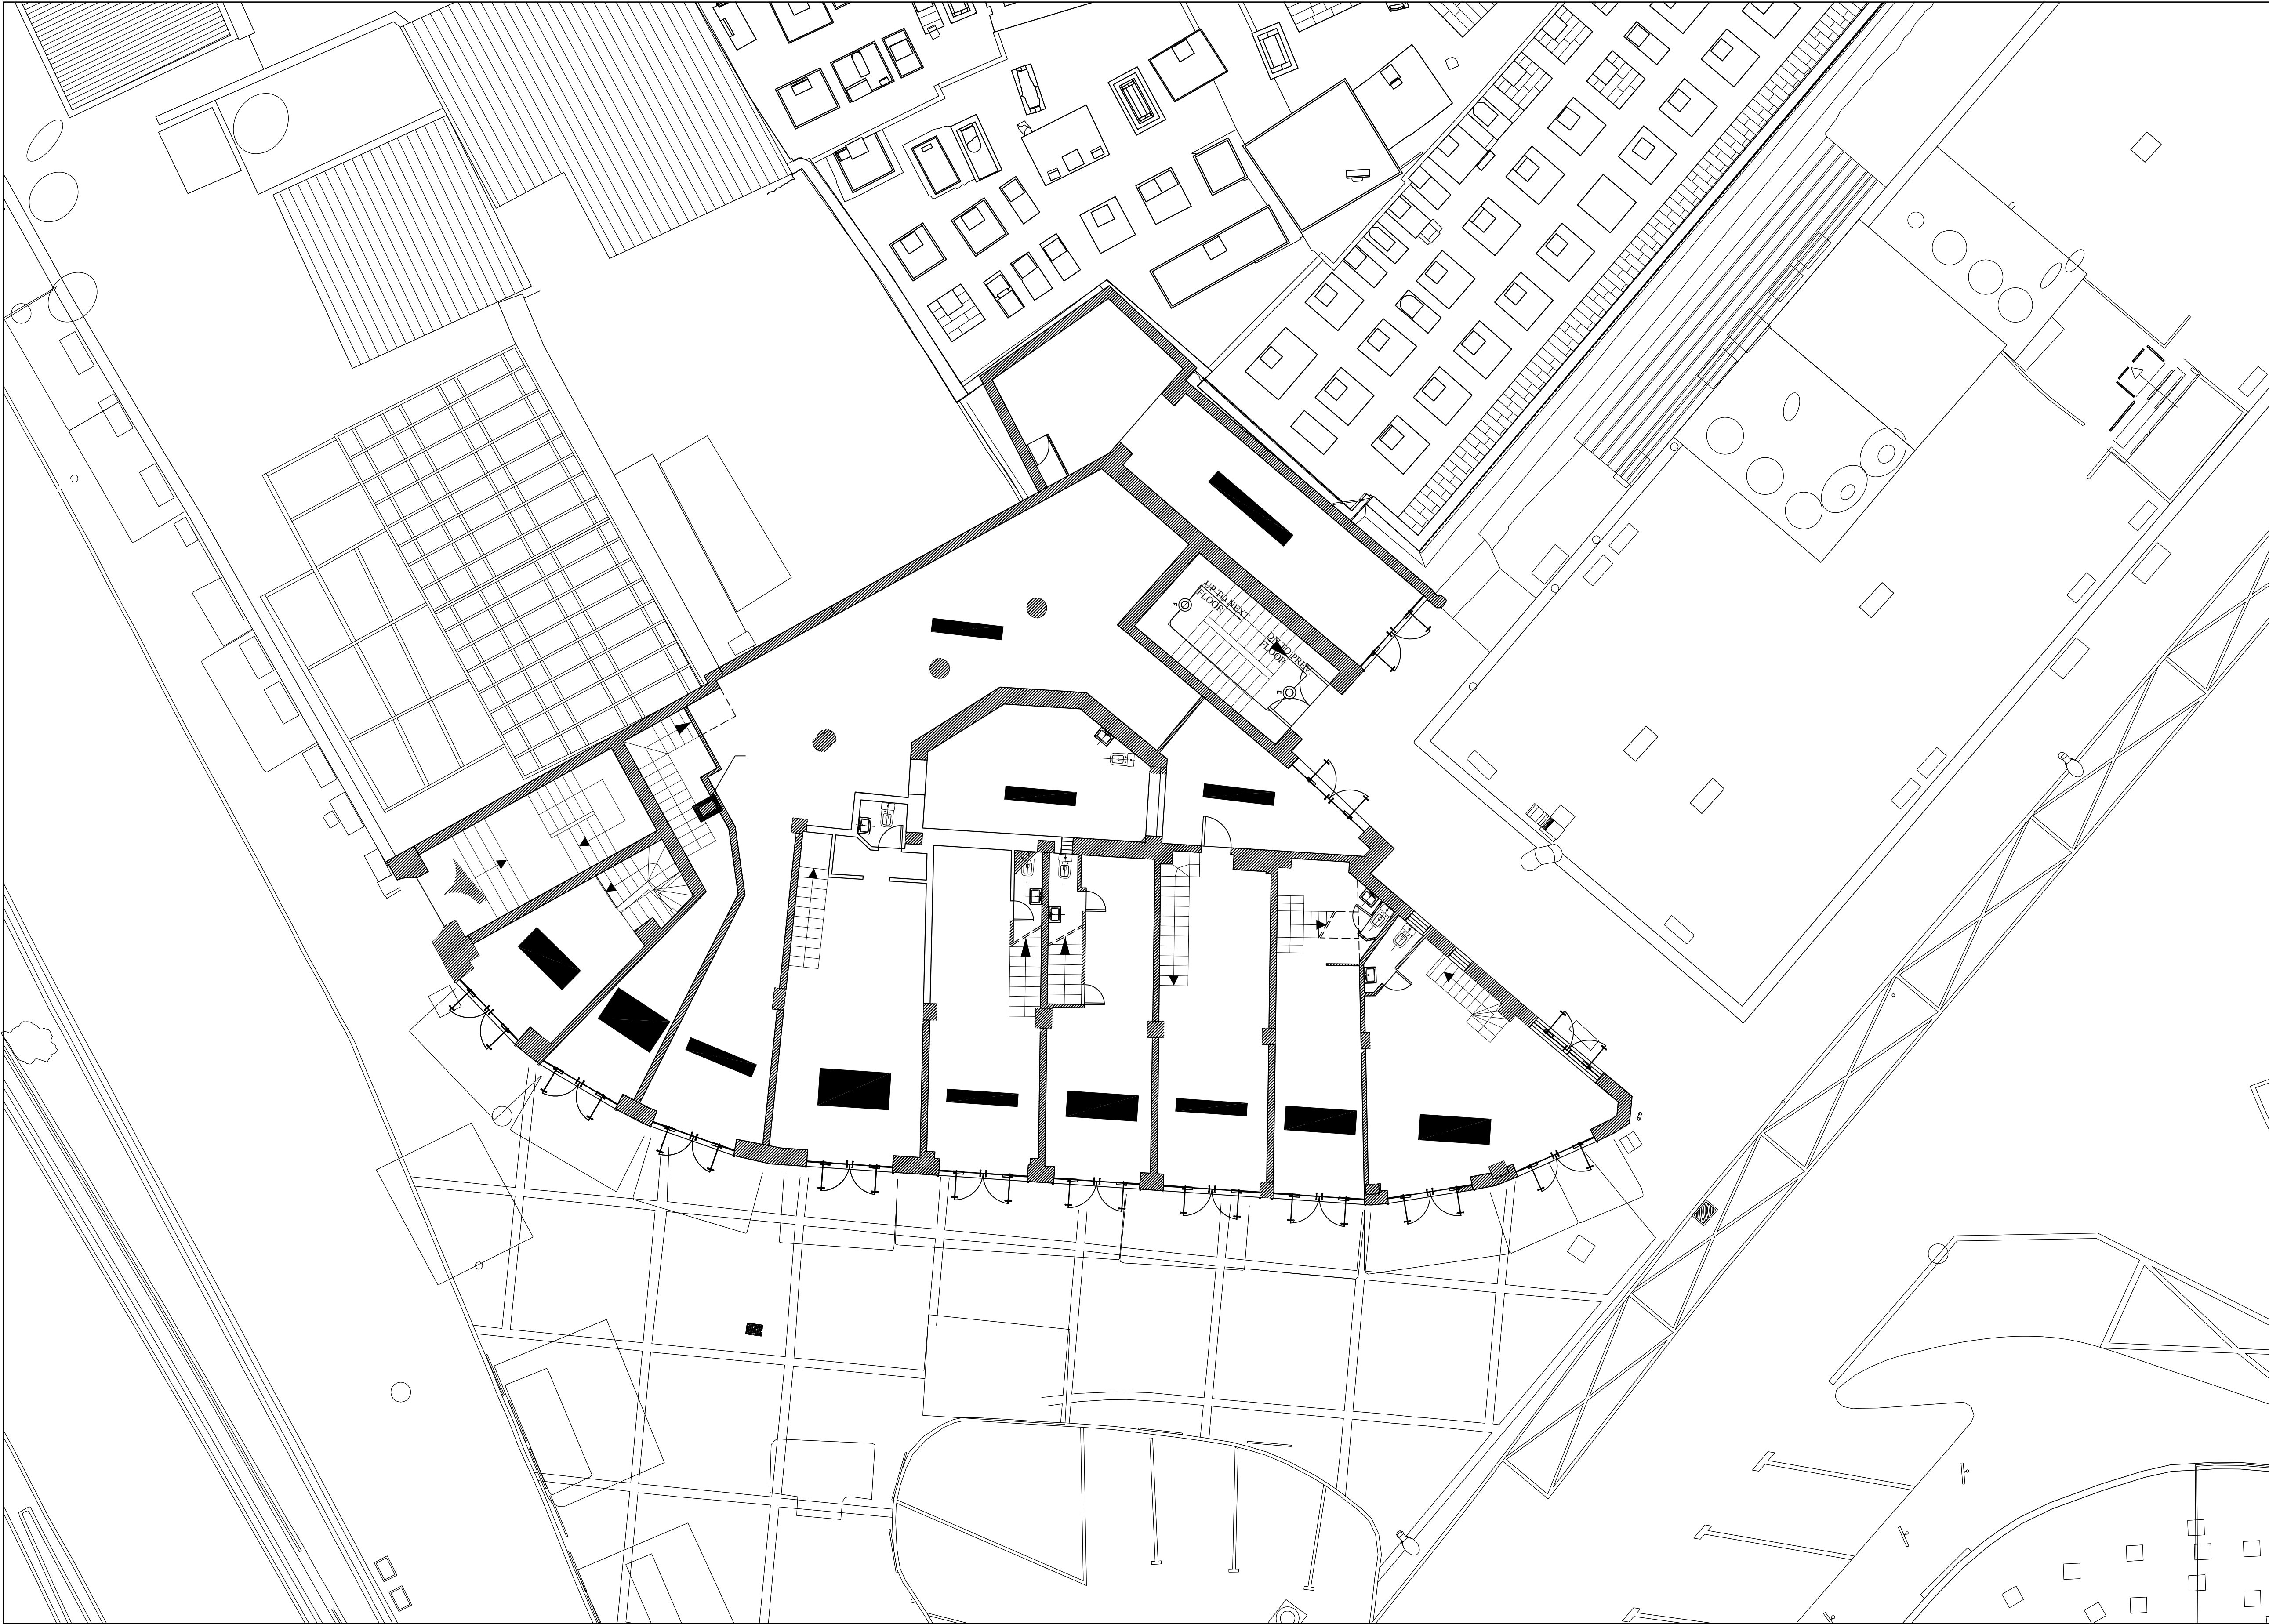


دائرة الأوقاف الإسلامية في القدس



UNDP
United Nations
Development Programme



EUROPEAN UNION

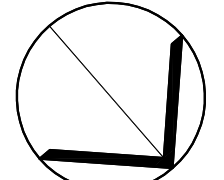

NORTH

03			
02			
01			
REV	SUBJECT	DATE	BY

NOTES:

LEGEND:

PROJECT TITLE

PRODUCTIVITY& URBAN RENEAL
IN EAST JERUSALEM (PURE)

RENOVATION WORKS OF
BUILDING SS001

SHEET TITLE:

Ground Floor
Lighting Points Plan

CONSULTANTS:




ZIADAH
ARCHITECTS & ENGINEERS
مهندسون ومهندسون



DOUR
ENGINEERING & PLANNING
CONSULTING ENGINEERS

Scale : 1:100 When Printed At A4 Sheet	Date : 01/11/2017
Design by : ZIADAH CONSULTANTS	 centimeters
checked by: ZIADAH CONSULTANTS	Division : ELECTRICAL
Drawn by: ZIADAH CONSULTANTS	SHEET NO. E4-01
Project No:1/16	

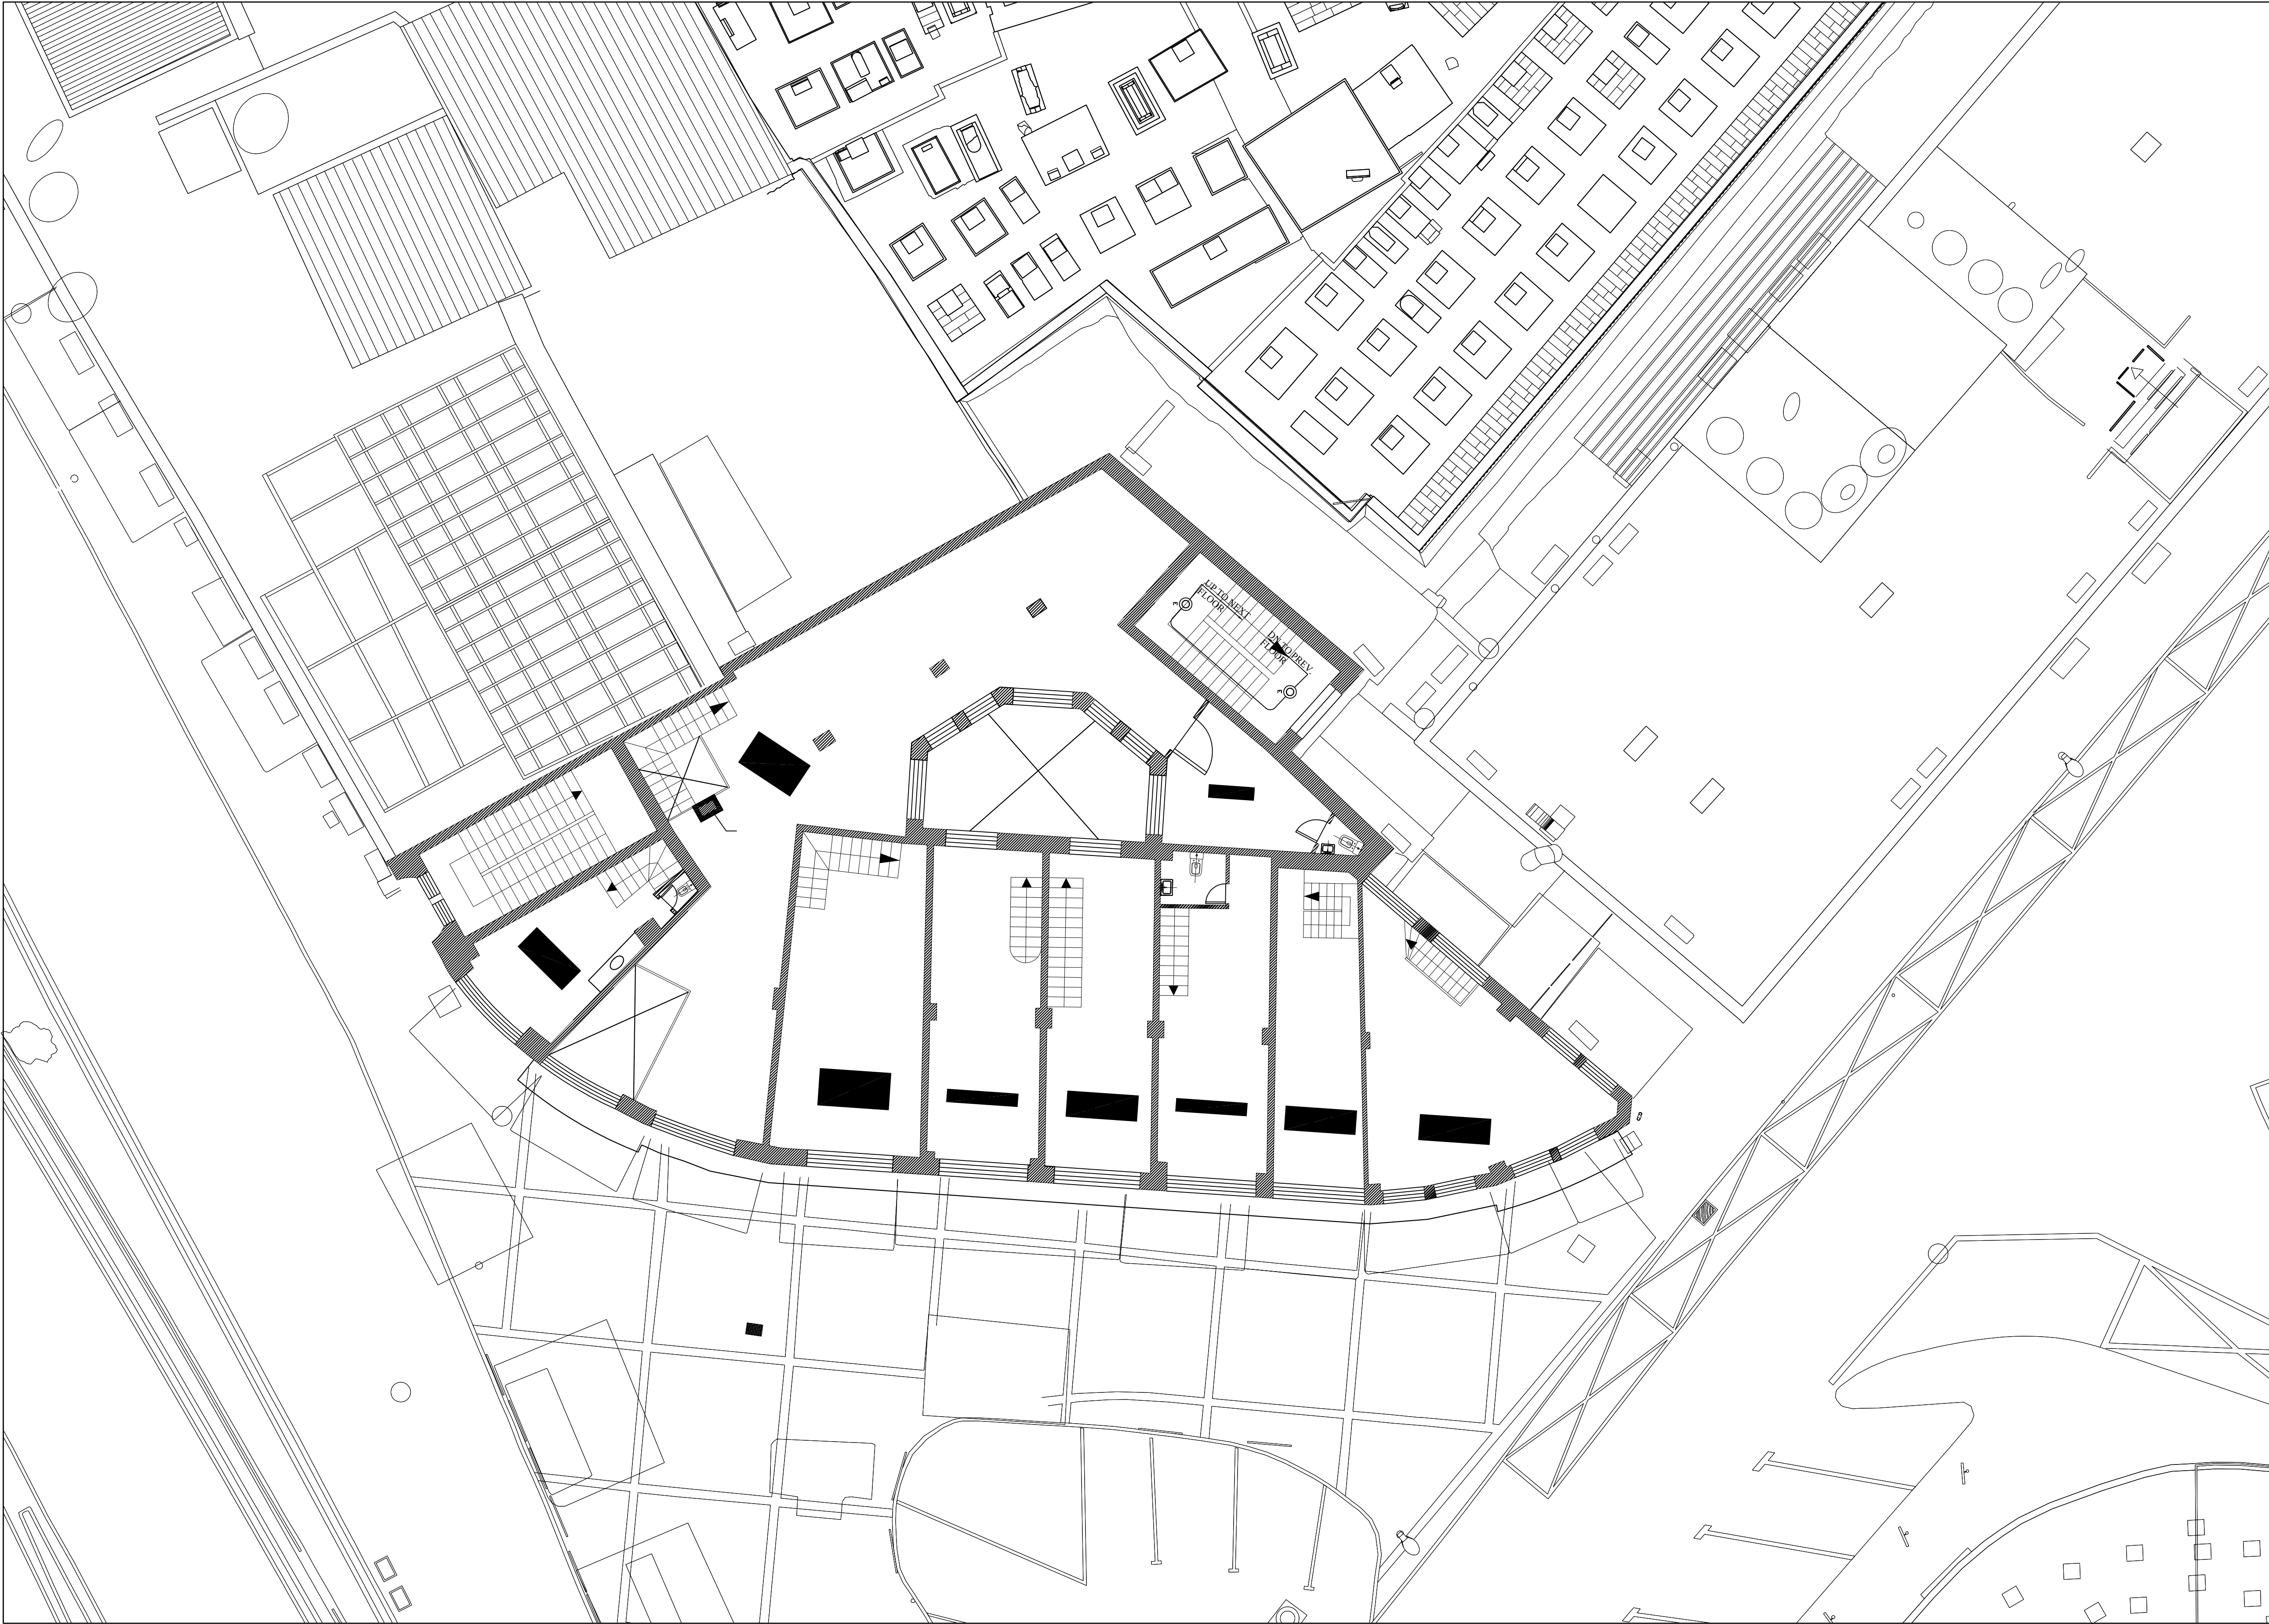


دائرة الأوقاف الإسلامية في القدس



UNDP
United Nations
Development Programme



EUROPEAN UNION

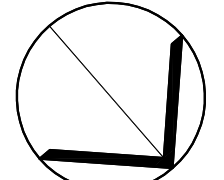

NORTH

03			
02			
01			
REV	SUBJECT	DATE	BY

NOTES:

LEGEND:

PROJECT TITLE

PRODUCTIVITY& URBAN RENEAL
IN EAST JERUSALEM (PURE)

RENOVATION WORKS OF
BUILDING SS001

SHEET TITLE:

**Mezzanine Floor
Lighting Points Plan**

CONSULTANTS:




ZIADAH
ARCHITECTS & ENGINEERS
مهندسون ومهندسون



DOUR
ENGINEERING & PLANNING
CONSULTING ENGINEERS

Scale : 1:100 When Printed At A4 Sheet	Date : 01/11/2017
Design by : ZIADAH CONSULTANTS	Division : ELECTRICAL
checked by: ZIADAH CONSULTANTS	SHEET NO. E4-02
Drawn by: ZIADAH CONSULTANTS	
Project No:1/16	

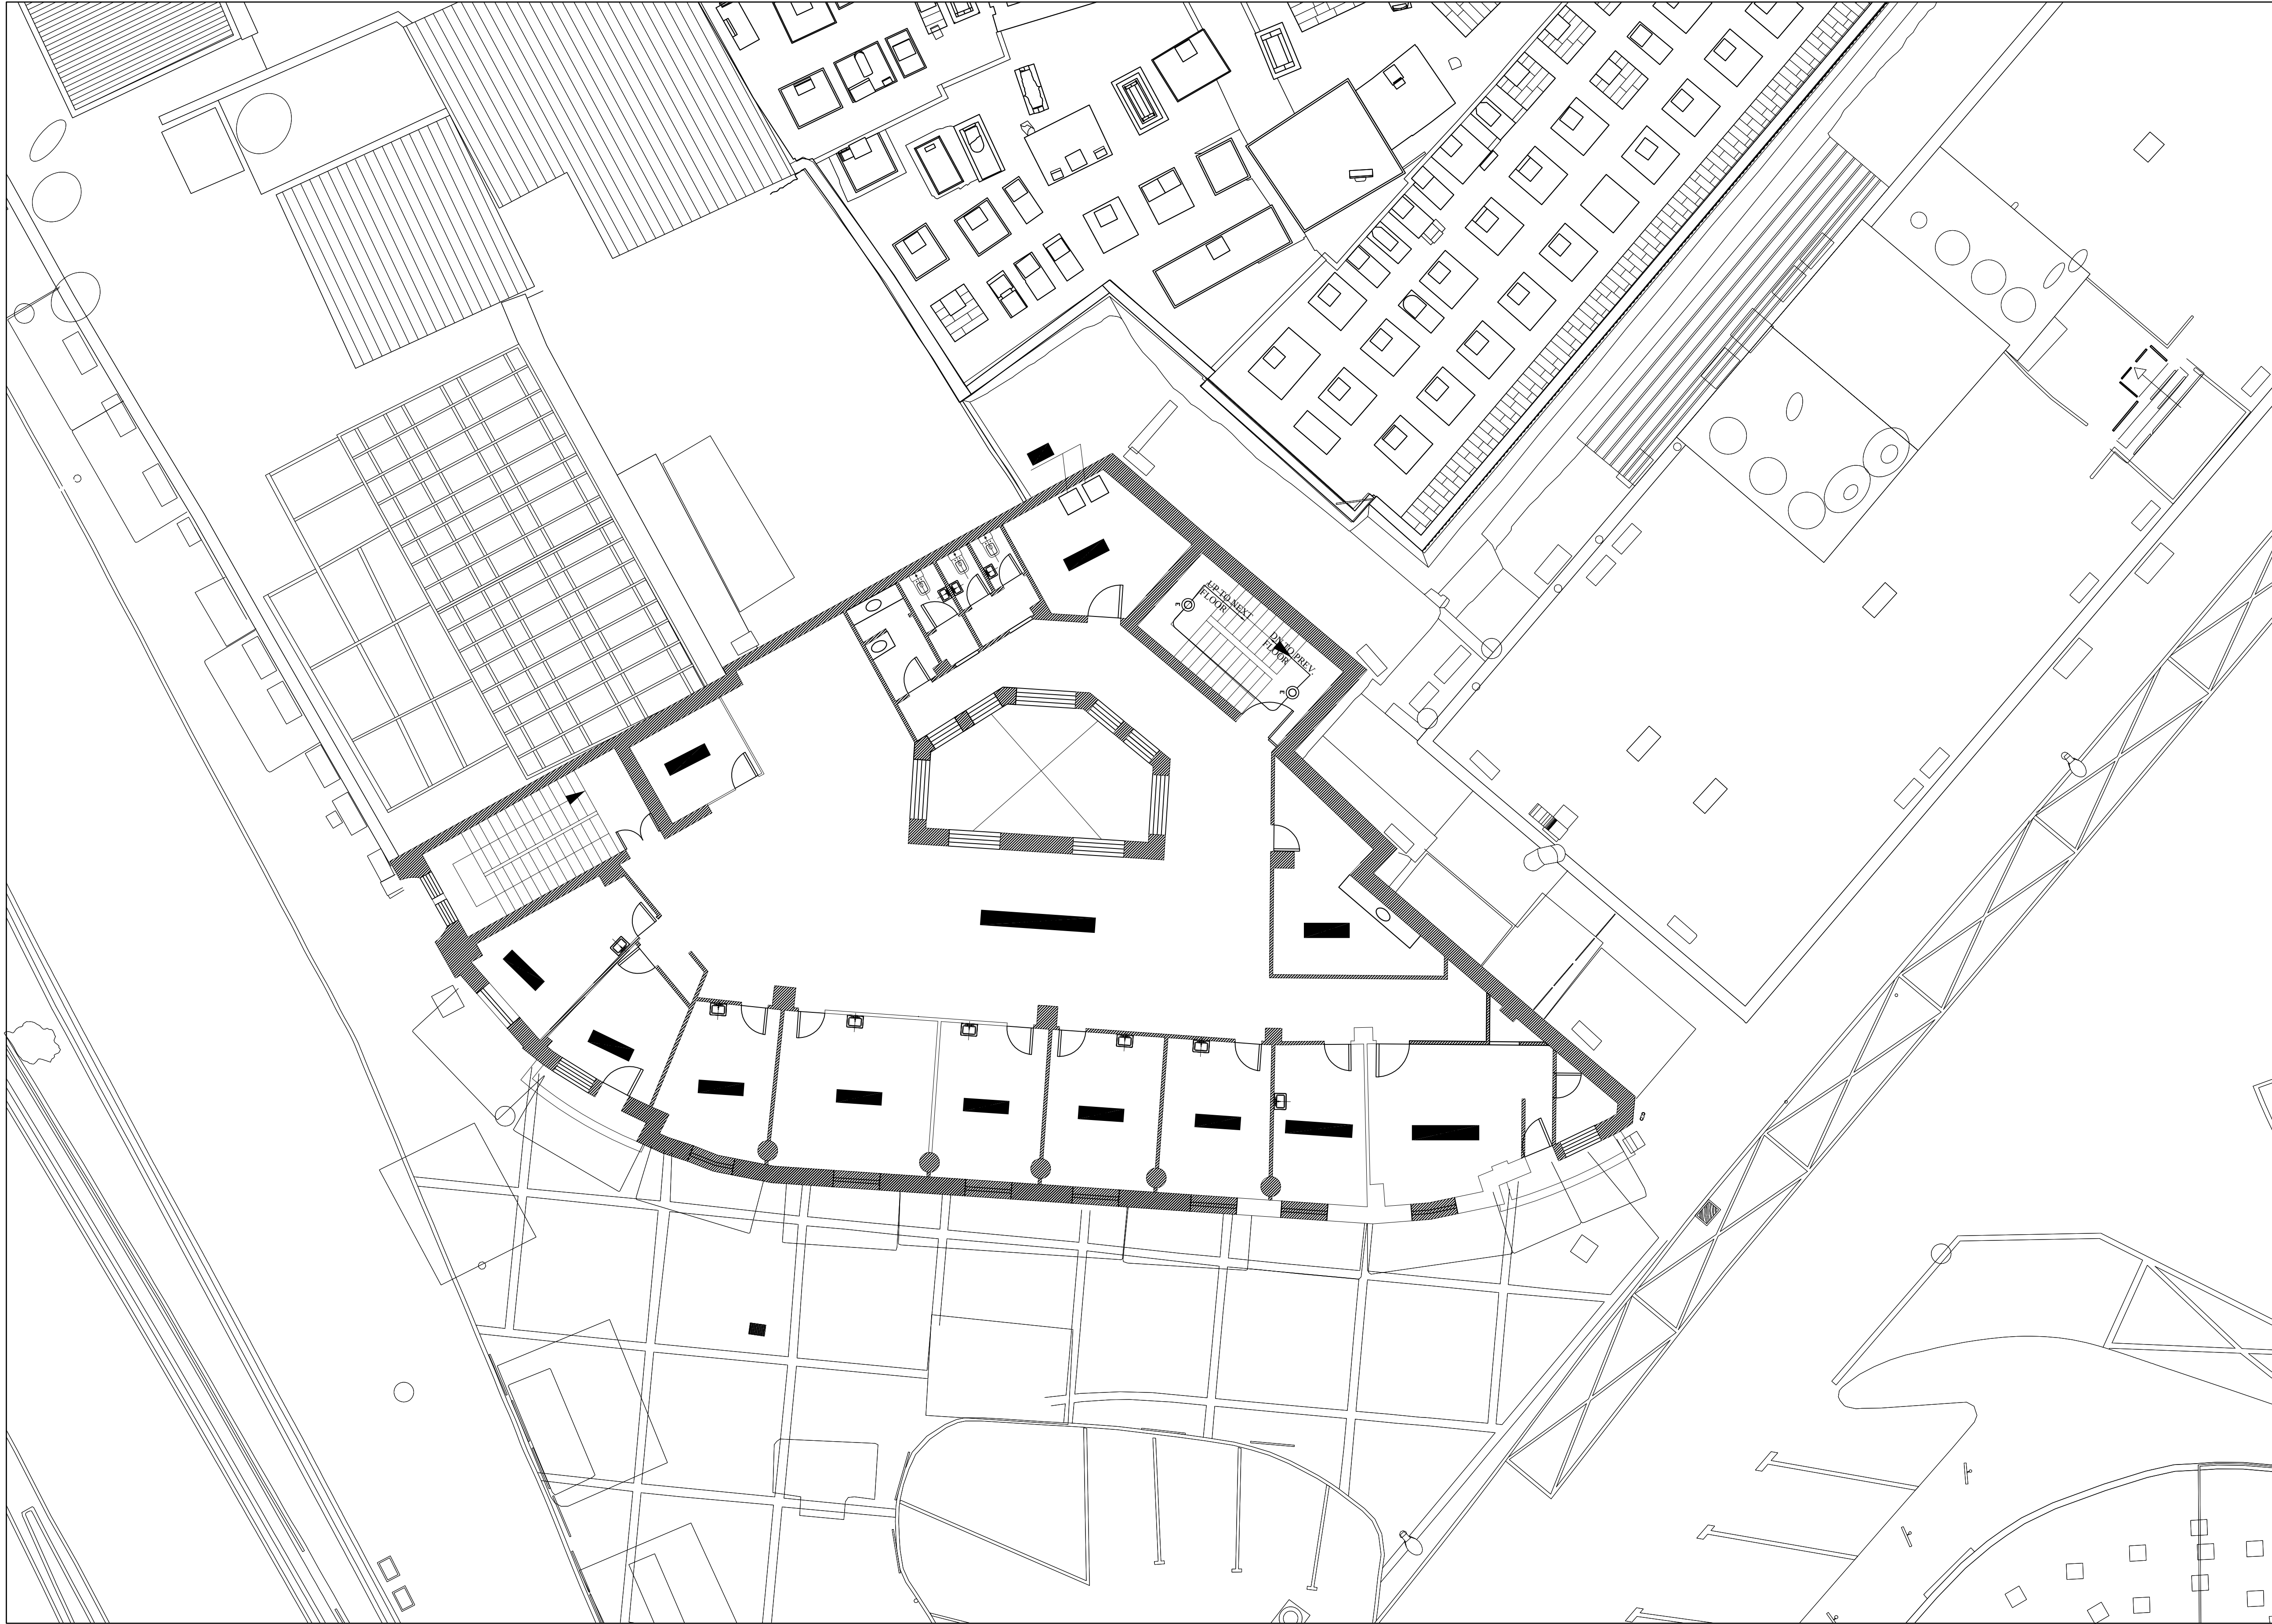


دائرة الأوقاف الإسلامية في القدس



هذا المشروع يدعمه من



EUROPEAN UNION

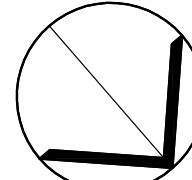

NORTH

03			
02			
01			
REV	SUBJECT	DATE	BY

NOTES:

LEGEND:

PROJECT TITLE

PRODUCTIVITY& URBAN RENEAL
IN EAST JERUSALEM (PURE)

RENOVATION WORKS OF
BUILDING SS001

SHEET TITLE:

**First Floor
Lighting Points Plan**

CONSULTANTS:




ARCHITECTS & ENGINEERS
مهندسون ومهندسون




ENGINEERING & PLANNING
CONSULTING ENGINEERS

Scale : 1:100 When Printed At A4 Sheet	Date : 01/11/2017
Design by : ZIADAH CONSULTANTS	Division : ELECTRICAL
checked by: ZIADAH CONSULTANTS	SHEET NO. E4-03
Drawn by: ZIADAH CONSULTANTS	
Project No:1/16	

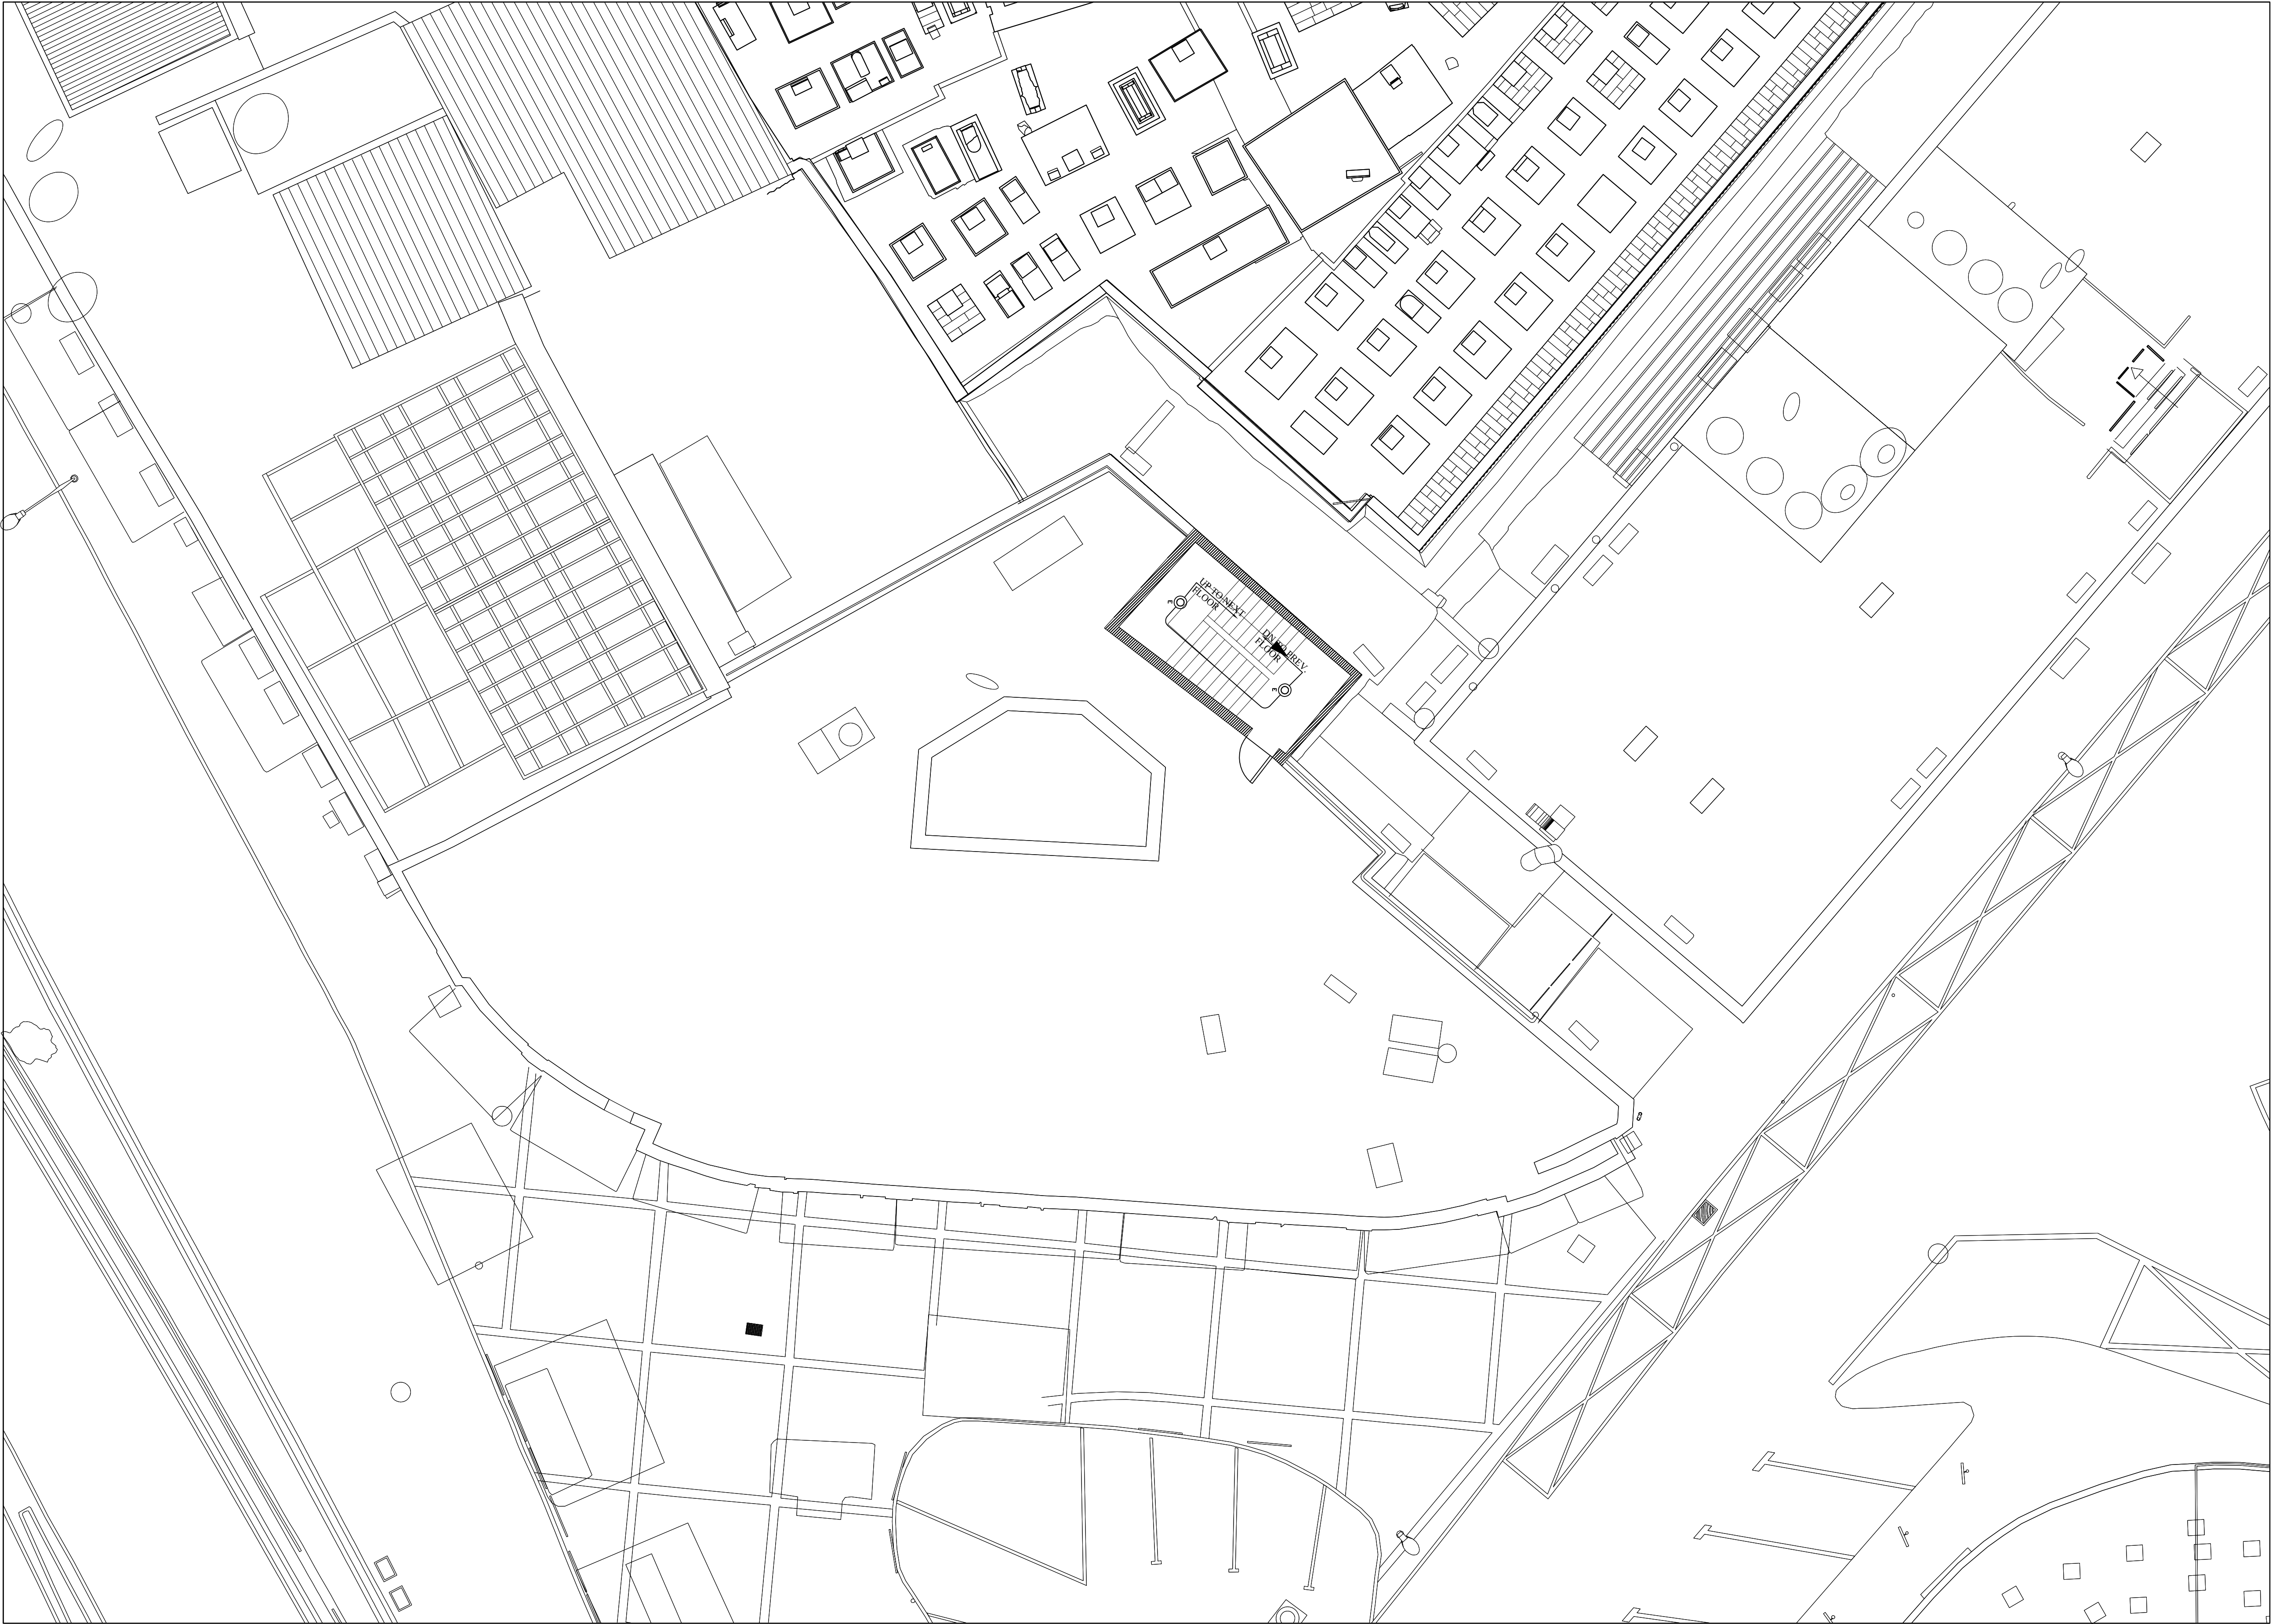

دائرة الأوقاف الإسلامية في القدس

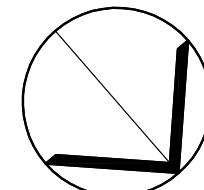

NORTH

03			
02			
01			
REV	SUBJECT	DATE	BY

NOTES:

LEGEND:

PROJECT TITLE
PRODUCTIVITY& URBAN RENEAL
IN EAST JERUSALEM (PURE)
RENOVATION WORKS OF
BUILDING SS001

SHEET TITLE:
**Roof Floor
Lighting Points Plan**

CONSULTANTS:
ZIADAH
ARCHITECTS & ENGINEERS
مهندسون وعلماء
DOUR
ENGINEERING & PLANNING
CONSULTING ENGINEERS

Scale : 1:100 When Printed At A3 Sheet	Date : 01/11/2017
Design by : ZIADAH CONSULTANTS	Division : ELECTRICAL
checked by: ZIADAH CONSULTANTS	SHEET NO. E4-04
Drawn by: ZIADAH CONSULTANTS	
Project No:1/16	


دائرة الأوقاف الإسلامية في القدس



UNDP
United Nations
Development Programme



EUROPEAN UNION

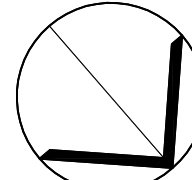

NORTH

03			
02			
01			
REV	SUBJECT	DATE	BY

NOTES:

LEGEND:

PROJECT TITLE

PRODUCTIVITY& URBAN RENEVAL
IN EAST JERUSALEM (PURE)

RENOVATION WORKS OF
BUILDING SS001

SHEET TITLE:

Electrical Schematic

CONSULTANTS:






ZIADAH
ARCHITECTS & ENGINEERS
مهندسون ومهندسون



DOUR
ENGINEERING & PLANNING
CONSULTING ENGINEERS

Scale : 1:100 When Printed At A4 Sheet	Date : 01/11/2017
Design by : ZIADAH CONSULTANTS	 centimeters
checked by: ZIADAH CONSULTANTS	
Drawn by: ZIADAH CONSULTANTS	Division : ELECTRICAL
Project No:1/16	SHEET NO. E5-01

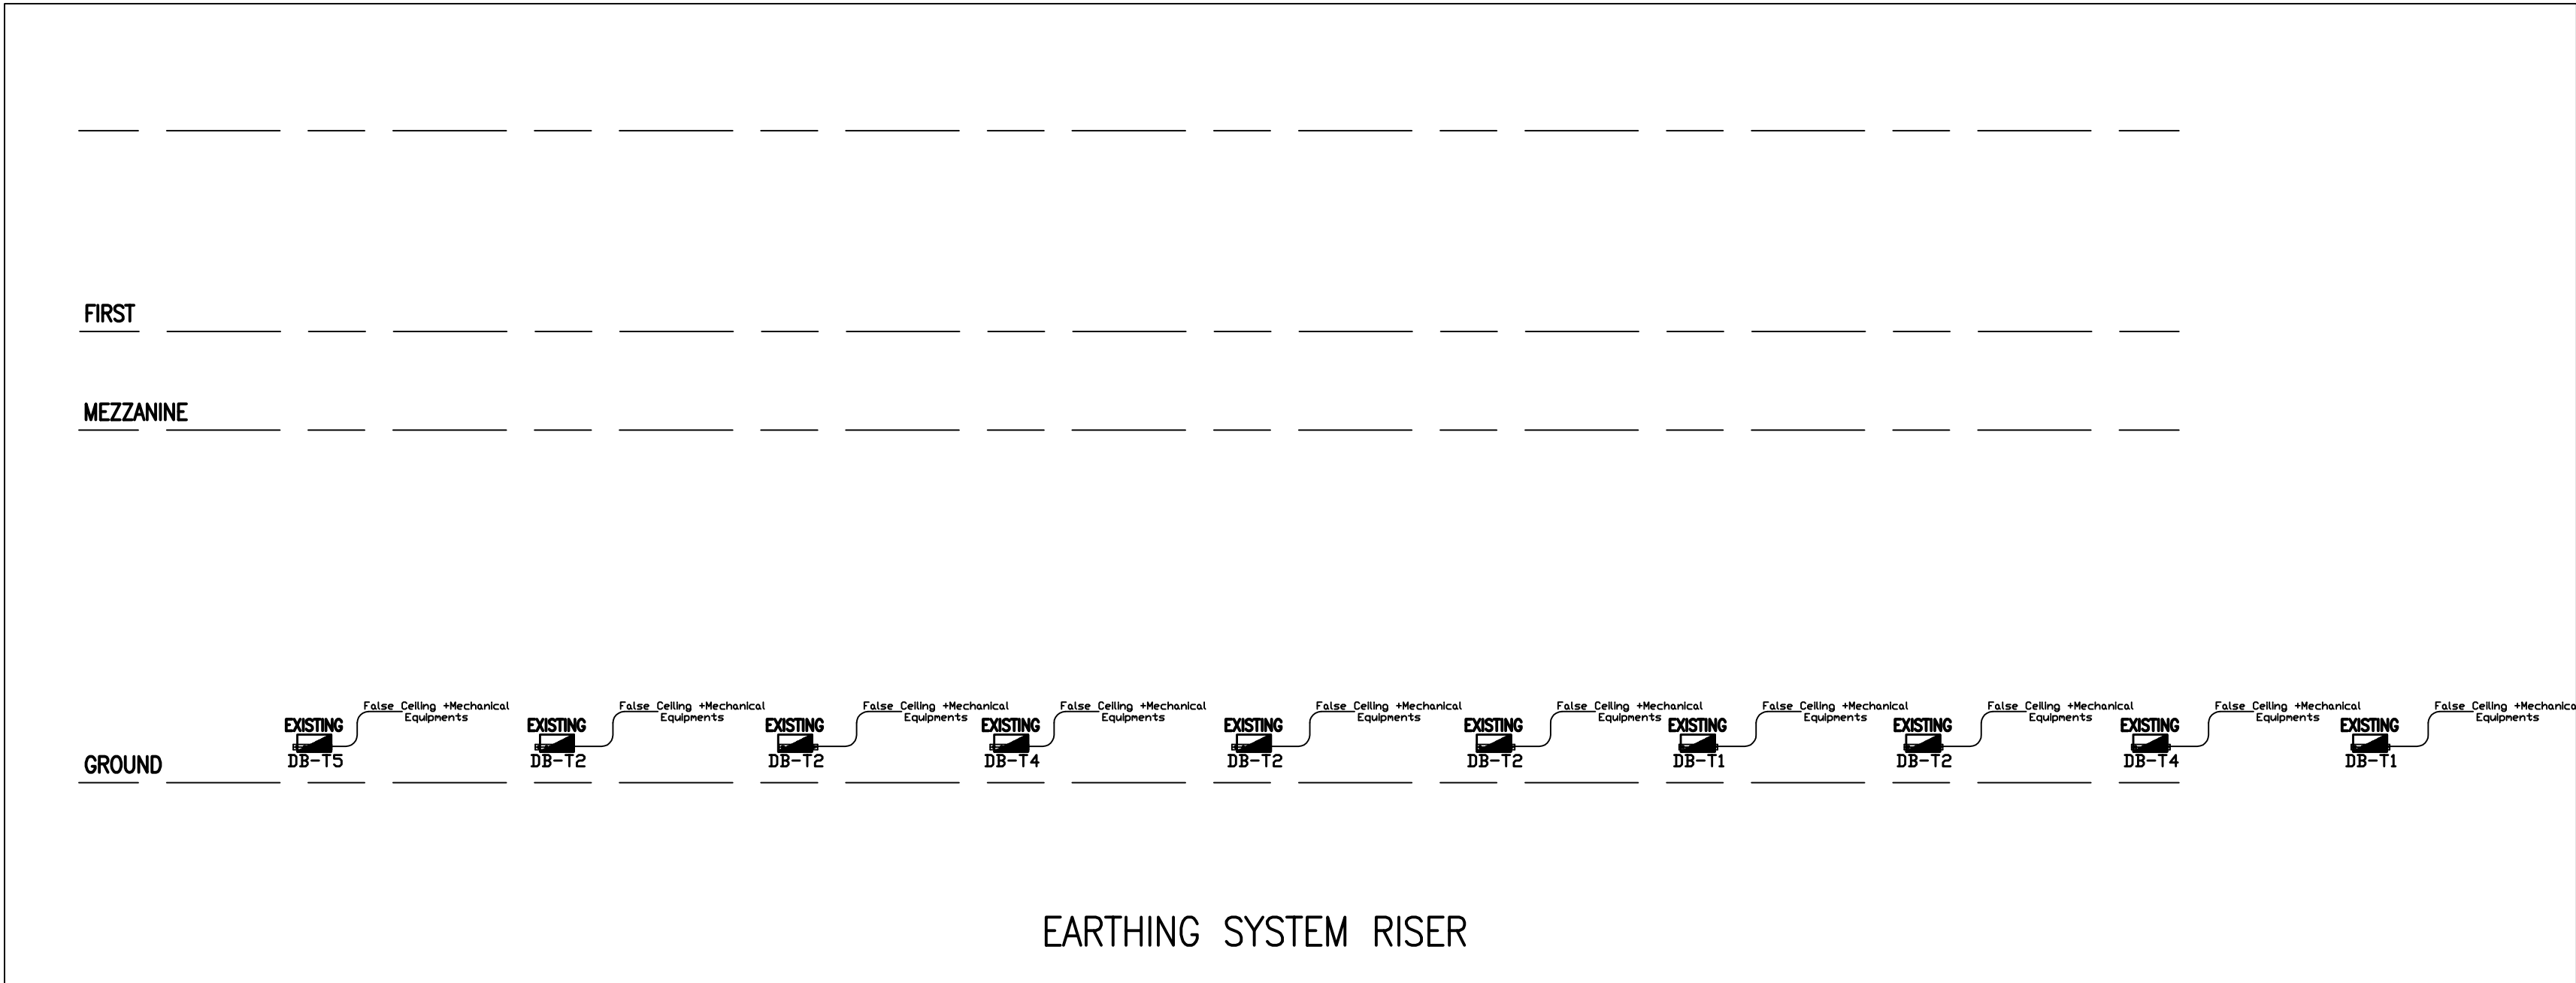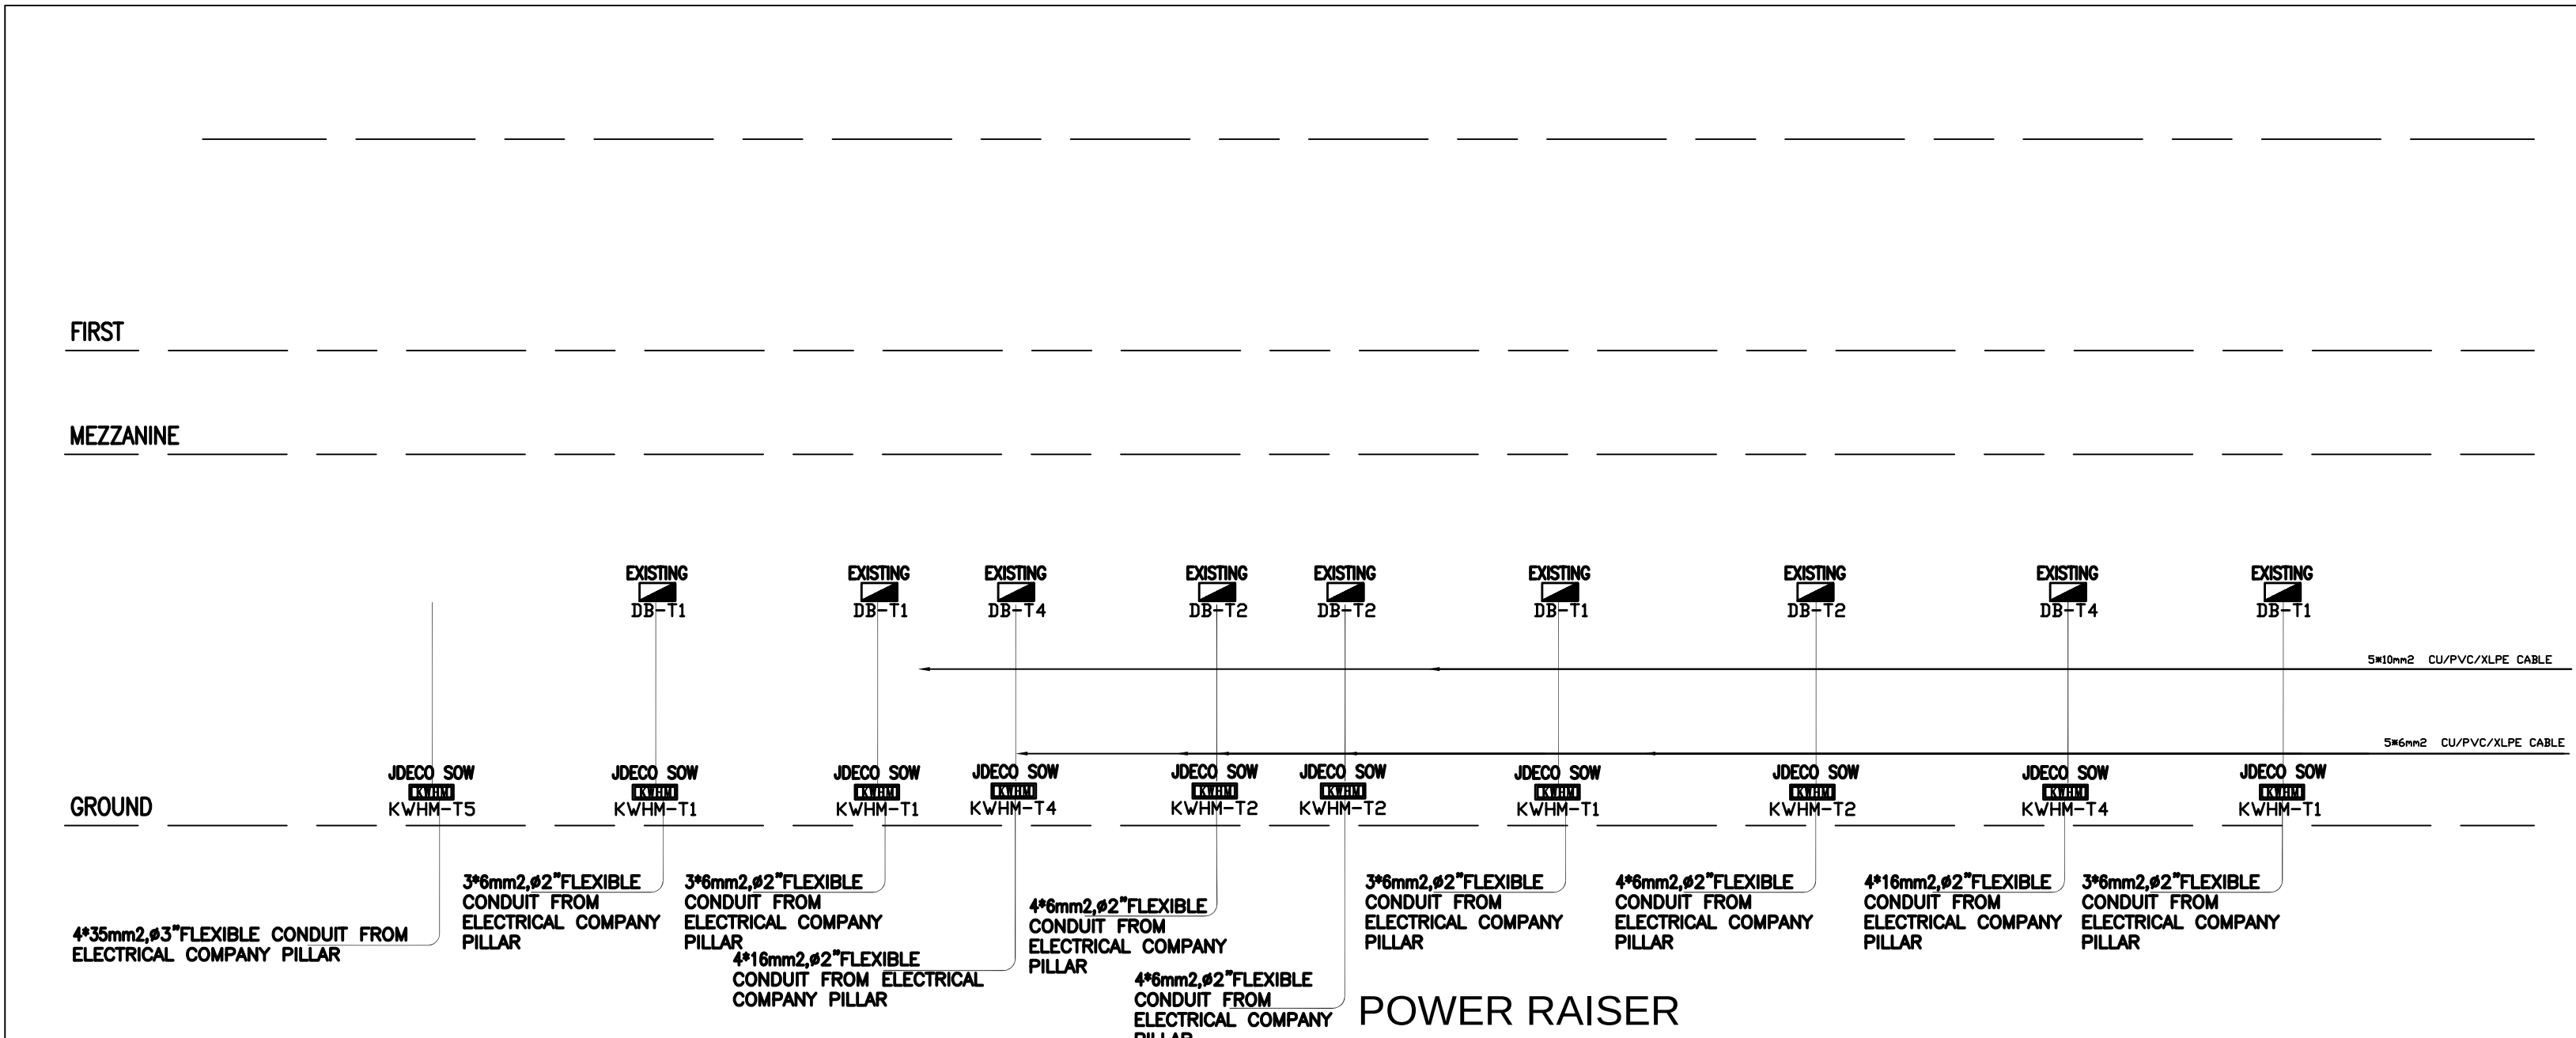

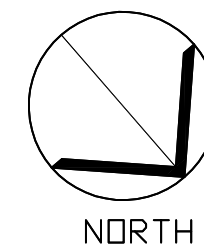

03			
02			
01			
REV	SUBJECT	DATE	BY

NOTES:

LEGEND:

PROJECT TITLE

PRODUCTIVITY & URBAN RENEWAL

IN EAST JERUSALEM (PURE)

RENOVATION WORKS OF
BUILDING SS001














SHEET TITLE:

Electrical Schematic

CONSULTANTS:




Scale : 1:100 When Printed At 60x90 cm	Date : 01/11/2017
Design by : ZIADAH CONSULTANTS	checked by : ZIADAH CONSULTANTS
Drawn by : ZIADAH CONSULTANTS	Project No: 116
Division : ELECTRICAL	SHEET NO. E6-01

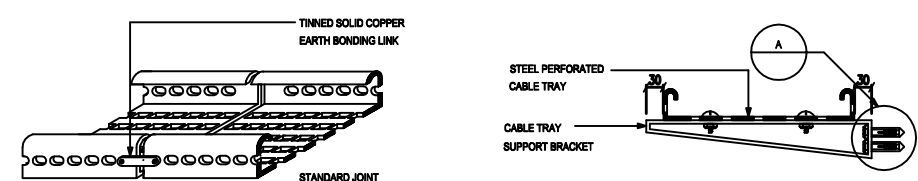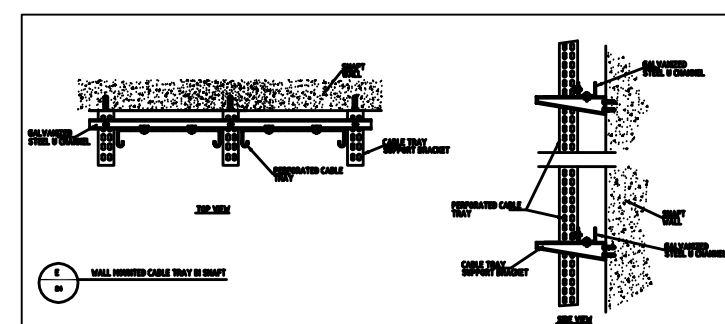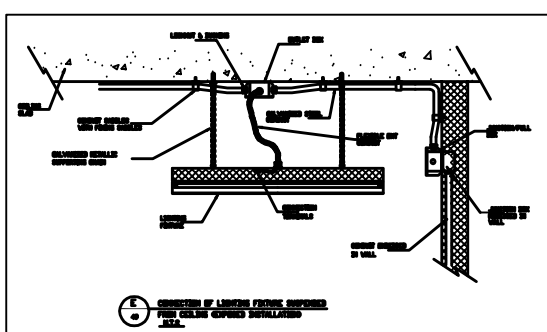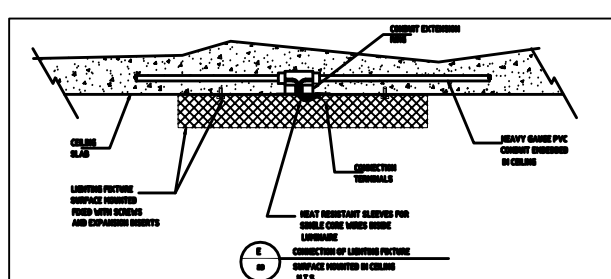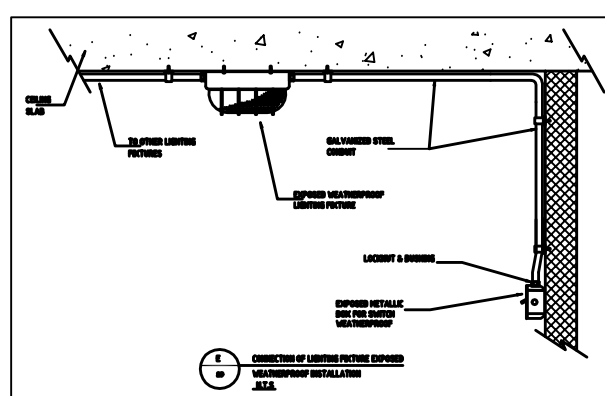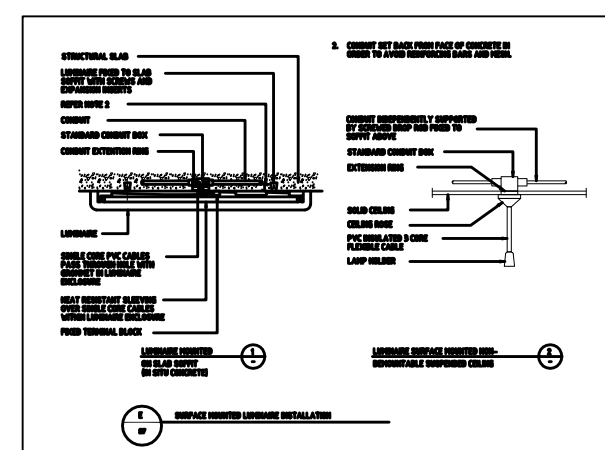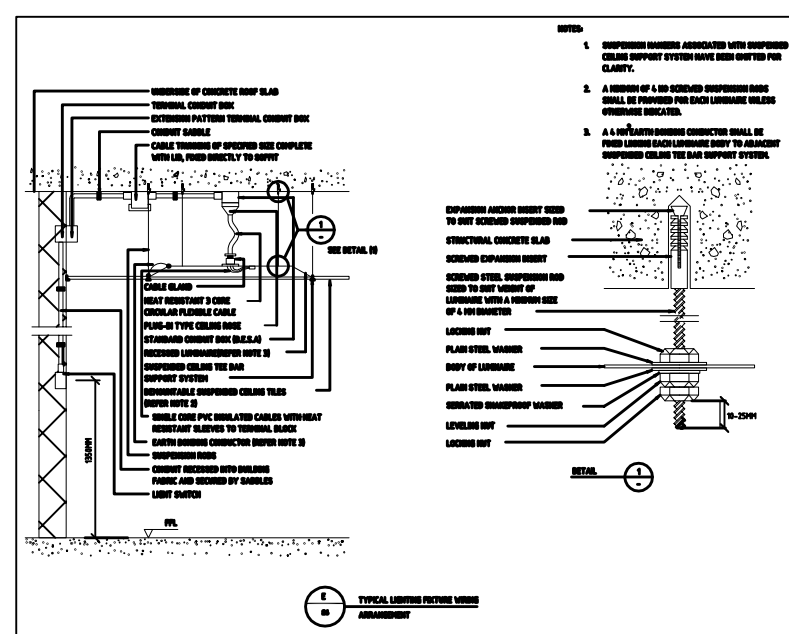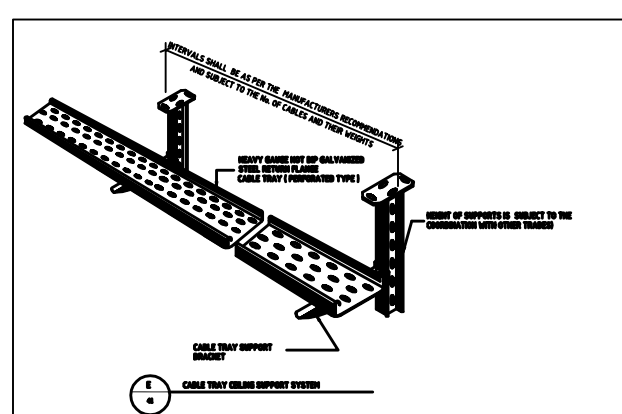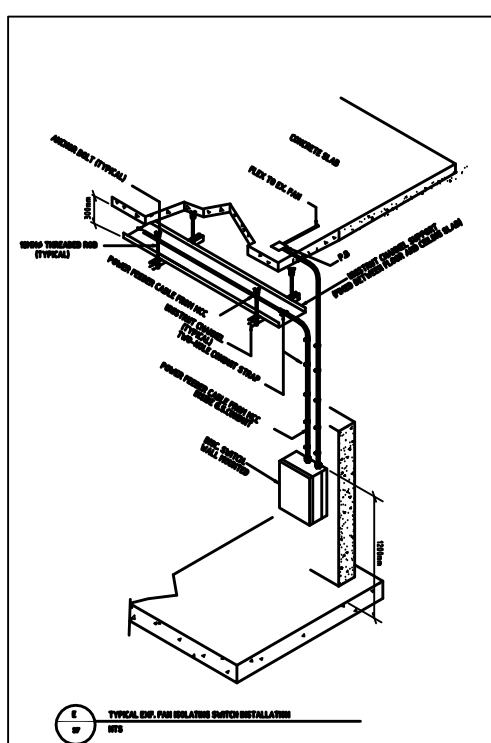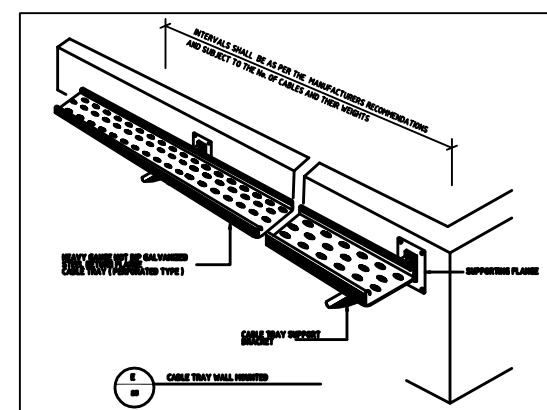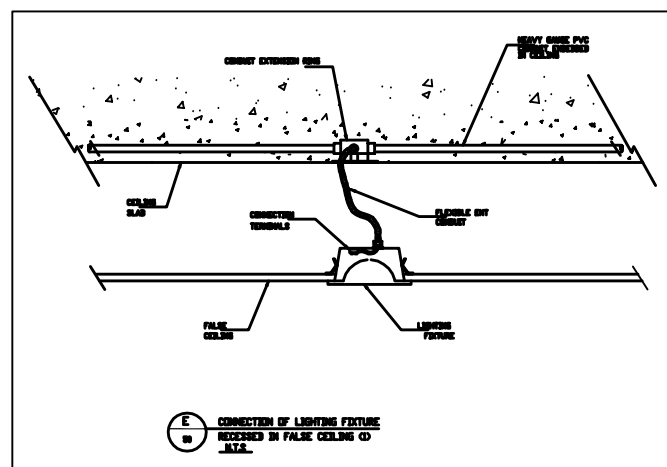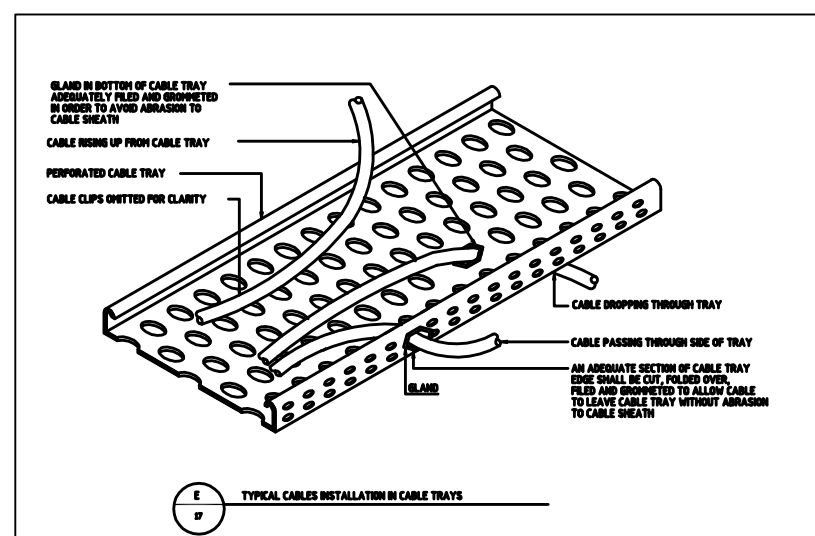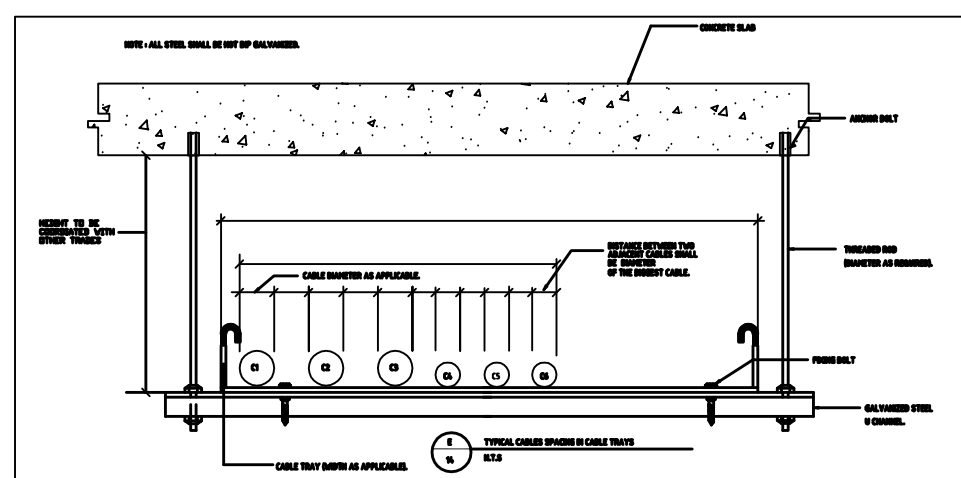


CABLE TRAY BONDING

WALL MOUNTED CABLE TRAY

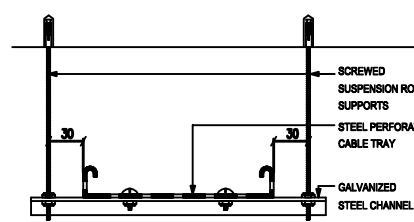


CEILING MOUNTED CABLE TRAY

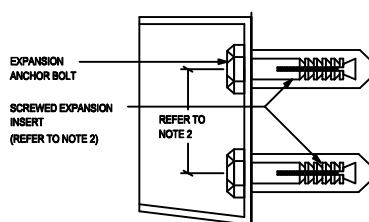


DETAIL (A)

NOTES:
1. EXACT METHOD OF JOINING THE CABLE TRAYS SHALL BE IN ACCORDANCE WITH THE RESPECTIVE MANUFACTURER'S RECOMMENDATIONS AND SHALL BE RESPONSIBLE TO THE RESPECTIVE PROPRIETARY COMPONENTS.


2. THE PRECISE DIMENSION AND SIZE OF ASSOCIATED EXPANSION ANCHOR BOLTS SHALL BE IN ACCORDANCE WITH BOTH THE RESPECTIVE MANUFACTURER'S RECOMMENDATIONS AND TO SUIT THE PROPRIETARY COMPONENTS.

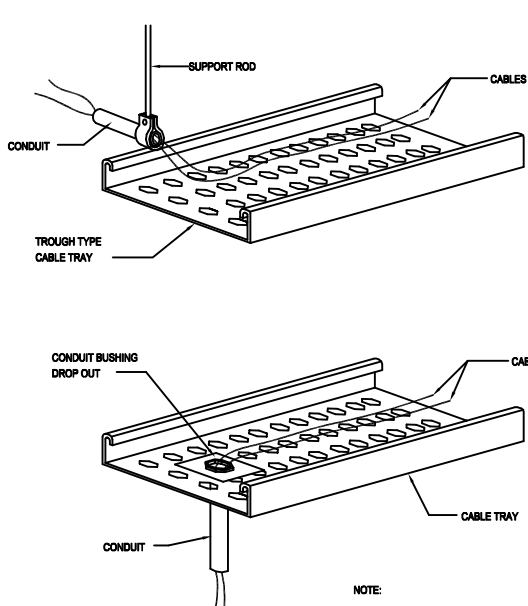


TRANSITION CABLE TRAY TO CONDUIT

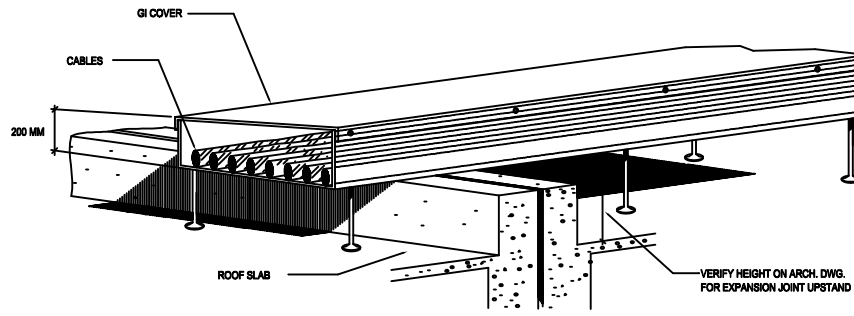


CABLE RACK DETAIL

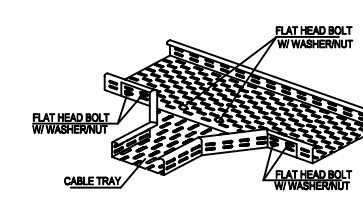


CABLE TRAY BRANCH

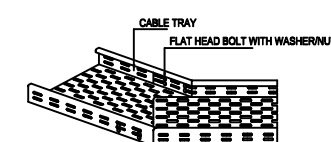


CABLE TRAY HORIZONTAL VARIABLE ANGLE PIECE

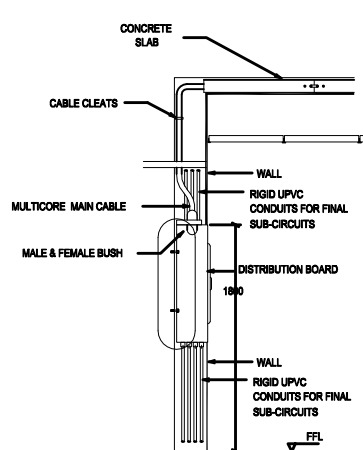


RECESSED DISTRIBUTION BOARD

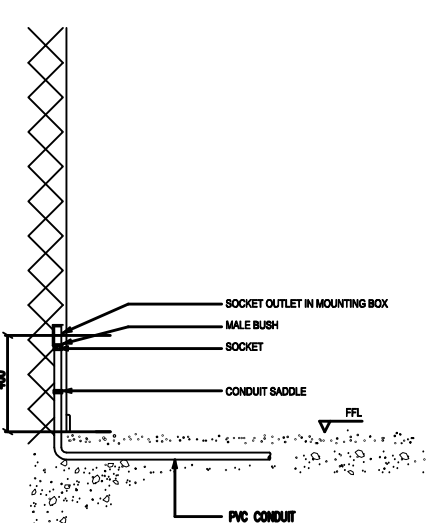

INSTALLATION OF SOCKET OUTLET

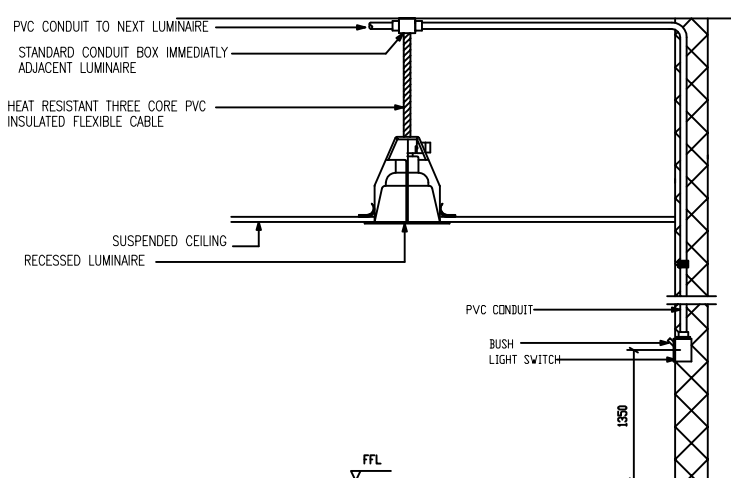

RECESSED LUMINAIRE IN SUSPENDED CEILING

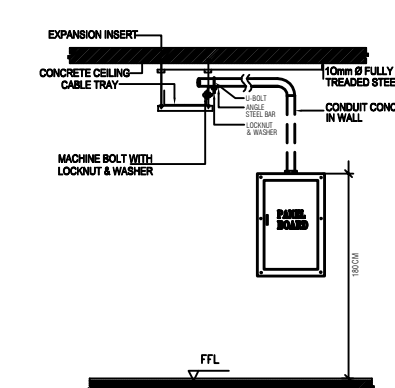

PANEL BOARD TO CABLE TRAY INSTALLATION DETAIL