

OWNER:

دائرة الأوقاف الإسلامية في القدس



PROJECT TITLE:

PRODUCTIVITY AND URBAN RENEWAL IN EAST JERUSALEM
(PURE)

Renovation Works of Buildings SS004

JERUSALEM

CONSULTANTS:



September 2017

OWNER:

دائرة الأوقاف الإسلامية في القدس



PROJECT TITLE:

PRODUCTIVITY AND URBAN RENEWAL IN EAST JERUSALEM
(PURE)

Renovation Works of Buildings SS004

Architectural Drawings

ARCHITECTURAL SHEETS LIST	
SHEET NUMBER	SHEET NAME
A0-01	Site Plan
A1-01-A	Ground Floor Plan
A1-01-B	Court Dimensions & Tiling Plan
A1-02	Mezzanine Floor Plan
A1-03	First Floor Plan
A1-04	Second Floor Plan
A1-05	Roof Floor Plan
A1-06	Roof Floor Interventions Plan
A1-07	Rain Water Drainage
A2-01	Elevations (1) & (2)
A2-02	Elevations (3) & (4)
A2-03	Elevations (5) & (6)
A2-04	Elevations (7) & (8)
A2-05	Elevations (9) & (10)
A2-06	Elevations (11), (12) & (13)
A2-07	Elevations (14) & (15)
A6-01	Doors & Windows


دائرة الأوقاف الإسلامية في القدس



UNDP
United Nations
Development
Programme



EUROPEAN UNION

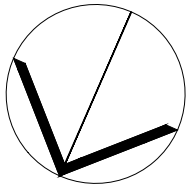

NORTH

03			
02			
01			
REV.	SUBJECT	DATE	BY

NOTES:
- All Levels in meter
- All dimensions are shown in centimeters.
.....
.....

LEGEND:

1- REINFORCED CONCRETE

2- CONCRETE

3- STONE

4- CONCRETE BLOCK

5- YTONG BLOCK

5- BASE COURSE

6- SAND

7- COMPACTED FILL OR NATURAL GROUND

8- LEVEL SYMBOL (PLAN)

10- LEVEL SYMBOL (SECTION - ELEVATION)

11- FINISH FLOOR LEVEL

12- CONCRETE FLOOR LEVEL

13- WINDOW LABEL

14- DOOR LABEL

15- DETAILS SIGN

16- STRUCTURAL SYMBOLS - COLUMNS

1- EXISTING COLUMN

2- RC COLUMN

3- COLUMN CONCRETE JACKETING

4- COLUMN STEEL JACKETING

* REF TO STRUCTURE DRAWINGS TO GET FINAL DATA

PROJECT TITLE

PRODUCTIVITY& URBAN RENEWAL
IN EAST JERUSALEM (PURE)

RENOVATION WORKS OF
BUILDING SS004

SHEET TITLE:

Index

CONSULTANTS:




ZIADAH
ARCHITECTS & ENGINEERS
معماريون ومهندسون



DOUR
ENGINEERING & PLANNING
CONSULTING ENGINEERS

Scale :	Date :
1:100 When Printed At Sheet (A1)	16 September 2017
Design by :	
ZIADAH CONSULTANTS	
checked by:	Division :
ZIADAH CONSULTANTS	ARCHITECTURAL
Drawn by:	SHEET NO.
ZIADAH CONSULTANTS	A0-00
Project No. 21/16	

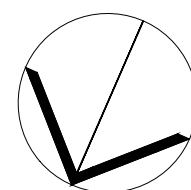

NORTH

03			
02			
01			
REV.	SUBJECT	DATE	BY

NOTES:
- All Levels in meter
- All dimensions are shown in centimeters.

LEGEND:	
1- REINFORCED CONCRETE	
2- CONCRETE	
3- STONE	
4- CONCRETE BLOCK	
5- YTONG BLOCK	
5- BASE COURSE	
6- SAND	
7- COMPACTED FILL OR NATURAL GROUND	
8- LEVEL SYMBOL (PLAN)	
10- LEVEL SYMBOL (SECTION - ELEVATION)	
11- FINISH FLOOR LEVEL	
12- CONCRETE FLOOR LEVEL	
13- WINDOW LABEL	
14- DOOR LABEL	
15- DETAILS SIGN	
16- STRUCTURAL SYMBOLS - COLUMNS	
1- EXISTING COLUMN	
2- RC COLUMN	
3- COLUMN CONCRETE JACKETING	
4- COLUMN STEEL JACKETING	
* REF TO STRUCTURE DRAWINGS TO GET FINAL DATA	

PROJECT TITLE
PRODUCTIVITY& URBAN RENEWAL
IN EAST JERUSALEM (PURE)
RENOVATION WORKS OF
BUILDING SS004

SHEET TITLE:
Site Plan


CONSULTANTS:
ZIADAH
ARCHITECTS & ENGINEERS
مهندسون وعلماء
DOUR
ENGINEERING & PLANNING
CONSULTING ENGINEERS

Scale : 1:100 When Printed At Sheet (A1)	Date : 16 September 2017
Design by : ZIADAH CONSULTANTS	
checked by : ZIADAH CONSULTANTS	Division : ARCHITECTURAL
Drawn by : ZIADAH CONSULTANTS	SHEET NO. A0-01
Project No. 21/16	





دائرة الأوقاف الإسلامية في القدس

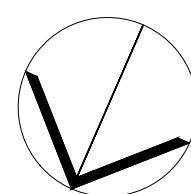

REV.	SUBJECT	DATE	BY
03			
02			
01			

NOTES:
- All Levels in meter
- All dimensions are shown in centimeters.

LEGEND:	
1- REINFORCED CONCRETE	
2- CONCRETE	
3- STONE	
4- CONCRETE BLOCK	
5- YTONG BLOCK	
6- SAND	
7- COMPACTED FILL OR NATURAL GROUND	
8- LEVEL SYMBOL (PLAN)	
10- LEVEL SYMBOL (SECTION - ELEVATION)	
11- FINISH FLOOR LEVEL	
12- CONCRETE FLOOR LEVEL	
13- WINDOW LABEL	
14- DOOR LABEL	
15- DETAILS SIGN	
16- STRUCTURAL SYMBOLS - COLUMNS	
1- EXISTING COLUMN	
2- RC COLUMN	
3- COLUMN CONCRETE JACKETING	
4- COLUMN STEEL JACKETING	
* REF TO STRUCTURE DRAWINGS TO GET FINAL DATA	


PROJECT TITLE
PRODUCTIVITY & URBAN RENEWAL
IN EAST JERUSALEM (PURE)
RENOVATION WORKS OF
BUILDING SS004

SHEET TITLE:
**Ground Floor
Plan**

CONSULTANTS:
ZIADAH
ARCHITECTS & ENGINEERS
مهندسون وعلماء
DOUR
ENGINEERING & PLANNING
CONSULTING ENGINEERS

Scale : 1:100 When Printed At Sheet (A1)	Date : 16 September 2017
Design by : ZIADAH CONSULTANTS	
checked by : ZIADAH CONSULTANTS	Division : ARCHITECTURAL
Drawn by : ZIADAH CONSULTANTS	SHEET NO.
Project No. : 21/16	A1-01-A

دائرة الأوقاف الإسلامية في القدس

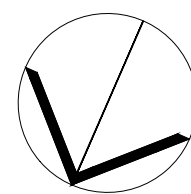

NORTH

03			
02			
01			
REV.	SUBJECT	DATE	BY

NOTES:
- All Levels in meter
- All dimensions are shown in centimeters.

LEGEND:	
1- REINFORCED CONCRETE	
2- CONCRETE	
3- STONE	
4- CONCRETE BLOCK	
5- YTONG BLOCK	
5- BASE COURSE	
6- SAND	
7- COMPACTED FILL OR NATURAL GROUND	
8- LEVEL SYMBOL (PLAN)	
10- LEVEL SYMBOL (SECTION - ELEVATION)	
11- FINISH FLOOR LEVEL	
12- CONCRETE FLOOR LEVEL	
13- WINDOW LABEL	
14- DOOR LABEL	
15- DETAILS SIGN	
16- STRUCTURAL SYMBOLS - COLUMNS	
1- EXISTING COLUMN	
2- RC COLUMN	
3- COLUMN CONCRETE JACKETING	
4- COLUMN STEEL JACKETING	
* REF TO STRUCTURE DRAWINGS TO GET FINAL DATA	

PROJECT TITLE
PRODUCTIVITY& URBAN RENEWAL
IN EAST JERUSALEM (PURE)
RENOVATION WORKS OF
BUILDING SS004

SHEET TITLE:
**Court Tiling &
Dimensions Plan**


CONSULTANTS:
ZIADAH
ARCHITECTS & ENGINEERS
معماريون ومهندسون
DOUR
ENGINEERING & PLANNING
CONSULTING ENGINEERS

Scale : 1:100 When Printed At Sheet (A1)	Date : 16 September 2017
Design by : ZIADAH CONSULTANTS	
checked by: ZIADAH CONSULTANTS	Division : ARCHITECTURAL
Drawn by: ZIADAH CONSULTANTS	SHEET NO.
Project No. 21/16	A1-01-B





دائرة الأوقاف الإسلامية في القدس

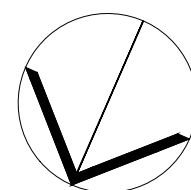

NORTH

03			
02			
01			
REV.	SUBJECT	DATE	BY

NOTES:
- All Levels in meter
- All dimensions are shown in centimeters.

LEGEND:	
1- REINFORCED CONCRETE	
2- CONCRETE	
3- STONE	
4- CONCRETE BLOCK	
5- YTONG BLOCK	
5- BASE COURSE	
6- SAND	
7- COMPACTED FILL OR NATURAL GROUND	
8- LEVEL SYMBOL (PLAN)	
10- LEVEL SYMBOL (SECTION - ELEVATION)	
11- FINISH FLOOR LEVEL	
12- CONCRETE FLOOR LEVEL	
13- WINDOW LABEL	
14- DOOR LABEL	
15- DETAILS SIGN	
16- STRUCTURAL SYMBOLS - COLUMNS	
1- EXISTING COLUMN	
2- RC COLUMN	
3- COLUMN CONCRETE JACKETING	
4- COLUMN STEEL JACKETING	
* REF TO STRUCTURE DRAWINGS TO GET FINAL DATA	

PROJECT TITLE
PRODUCTIVITY& URBAN RENEWAL
IN EAST JERUSALEM (PURE)


RENOVATION WORKS OF
BUILDING SS004

SHEET TITLE:
**Mezzanine Floor
Plan**

CONSULTANTS:
ZIADAH
ARCHITECTS & ENGINEERS
معماريون ومهندسون

DOUR
ENGINEERING & PLANNING
CONSULTING ENGINEERS

Scale : 1:100 When Printed At Sheet (A1)	Date : 16 September 2017
Design by : ZIADAH CONSULTANTS	
checked by: ZIADAH CONSULTANTS	Division : ARCHITECTURAL
Drawn by: ZIADAH CONSULTANTS	SHEET NO. A1-02
Project No. 21/16	

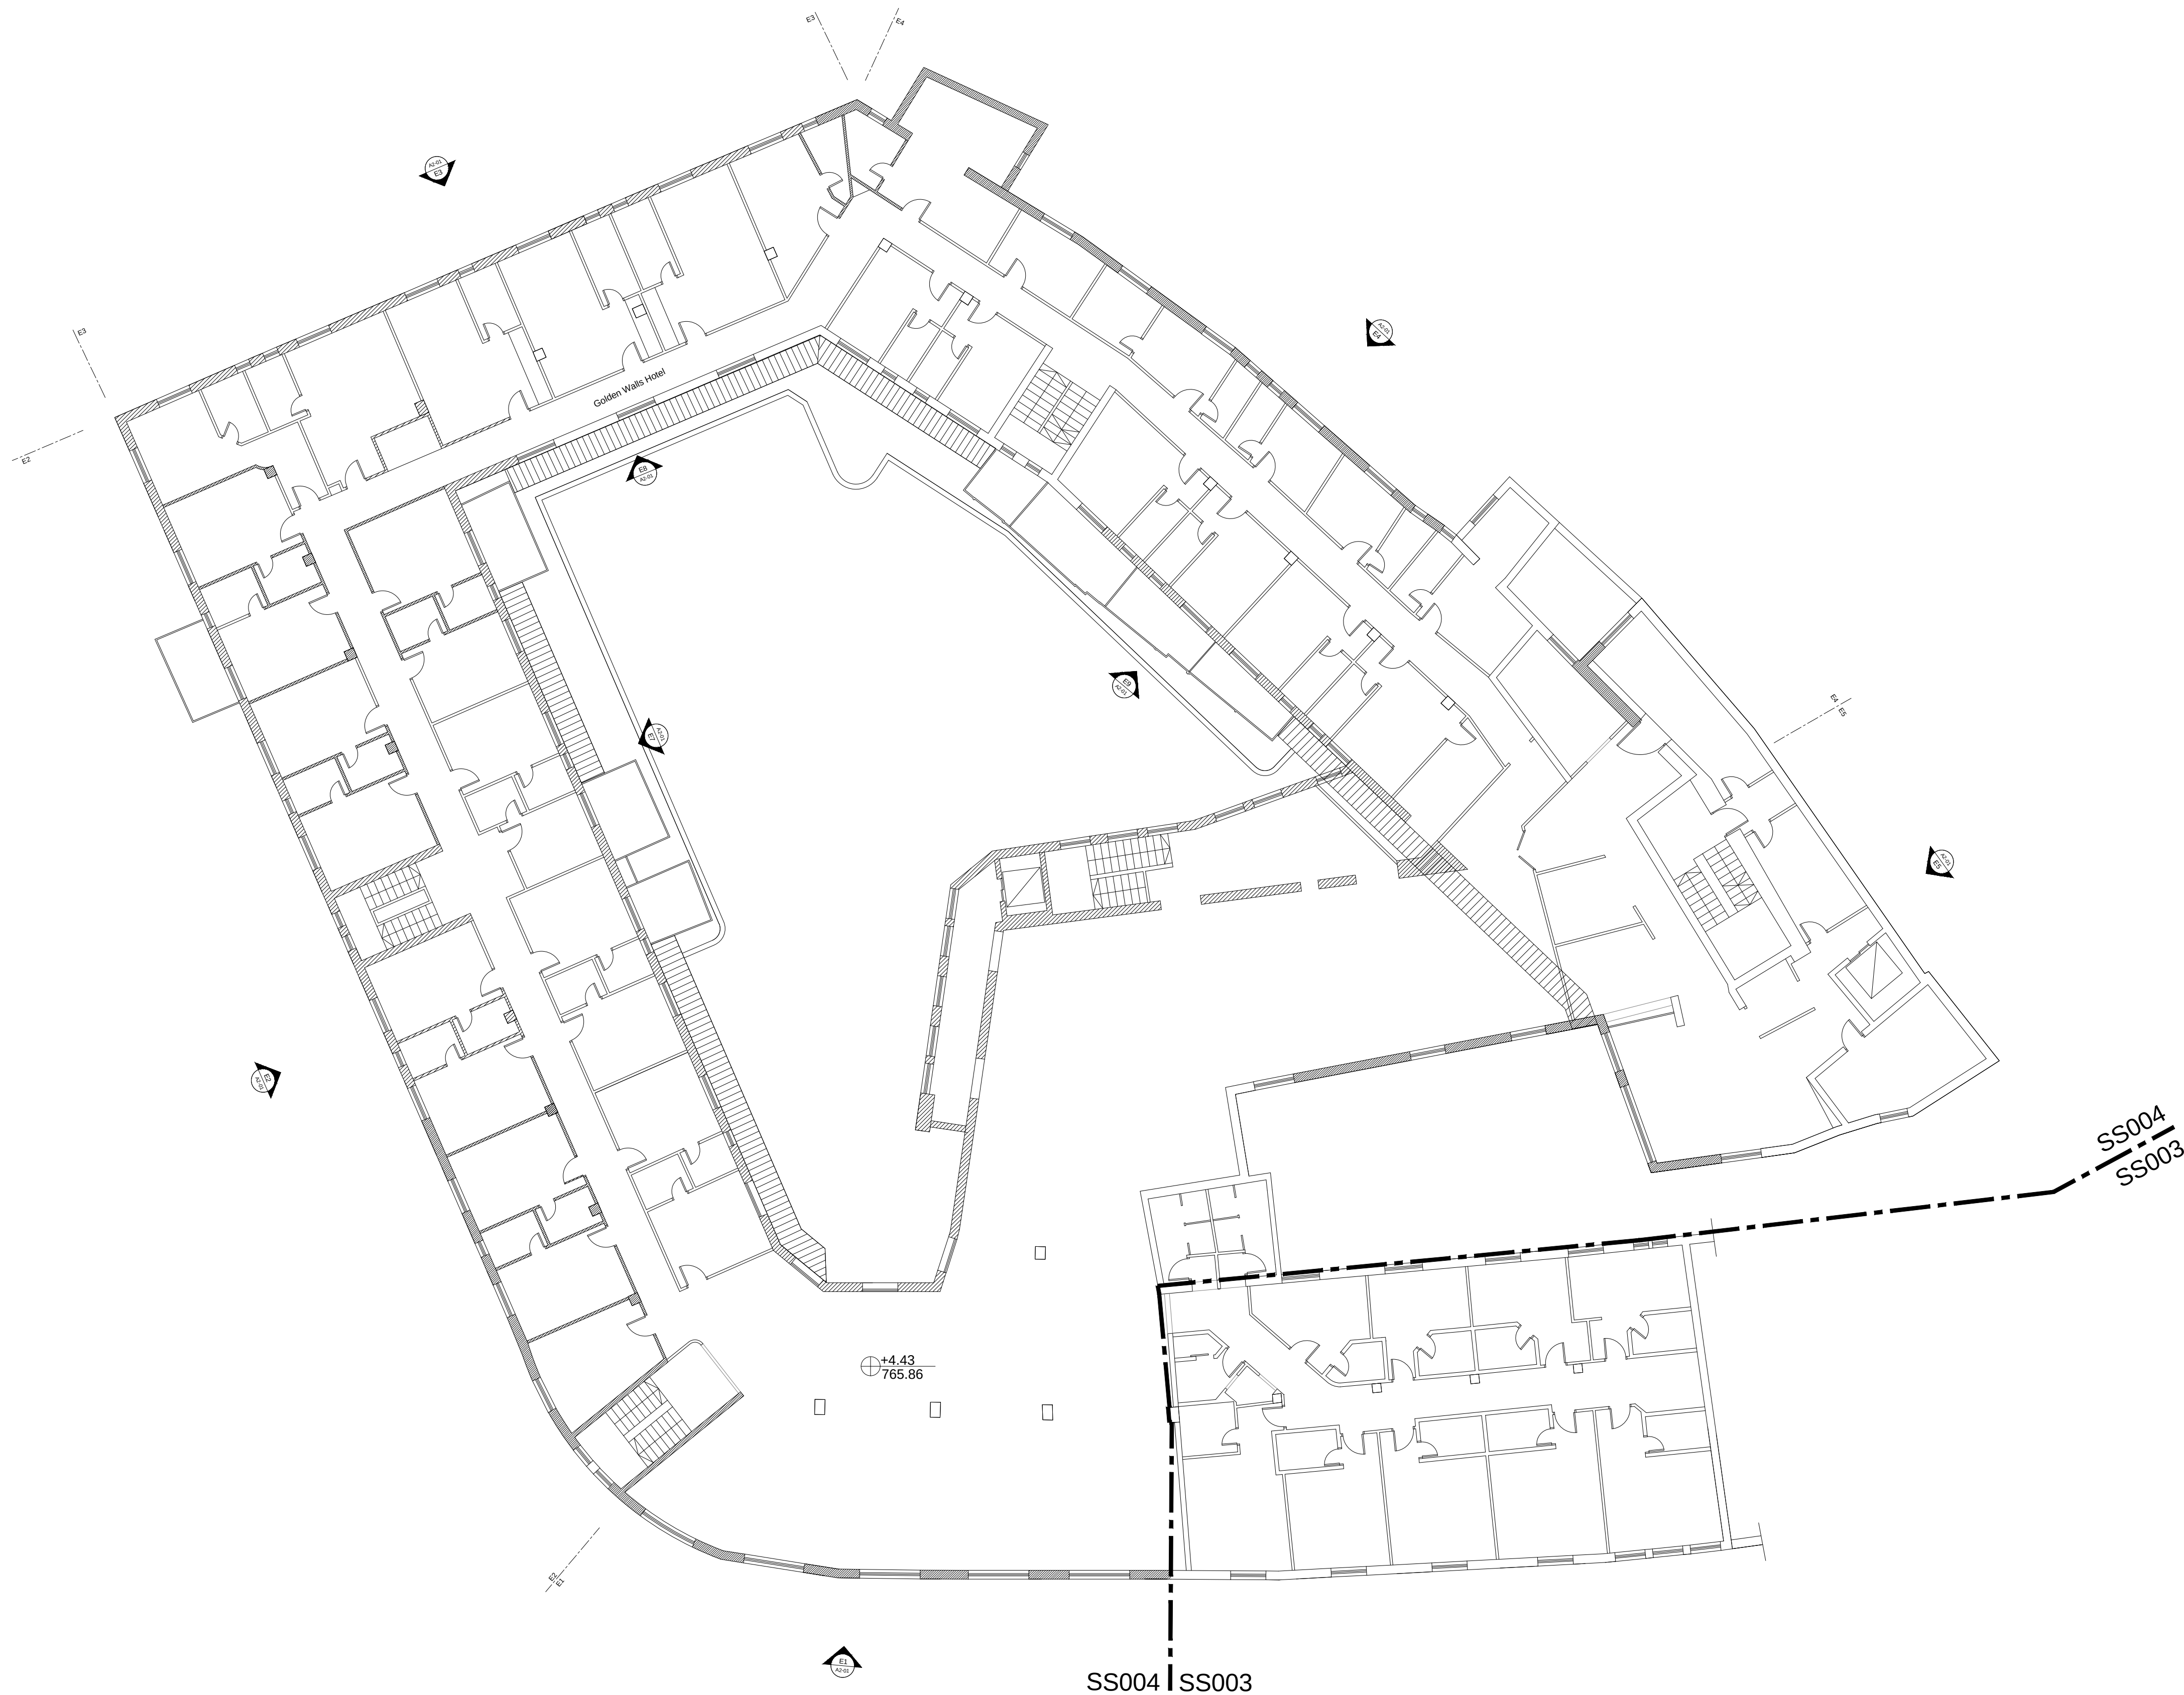


دائرة الأوقاف الإسلامية في القدس



UNDP
United Nations
Development Programme



EUROPEAN UNION

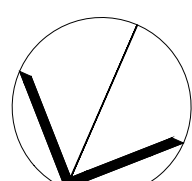

NORTH

03			
02			
01			
REV.	SUBJECT	DATE	BY

NOTES:

- All Levels in meter
- All dimensions are shown in centimeters.

LEGEND:

1- REINFORCED CONCRETE

2- CONCRETE

3- STONE

4- CONCRETE BLOCK

5- YTONG BLOCK

5- BASE COURSE

6- SAND

7- COMPACTED FILL OR NATURAL GROUND

8- LEVEL SYMBOL (PLAN)

10- LEVEL SYMBOL (SECTION - ELEVATION)

11- FINISH FLOOR LEVEL

12- CONCRETE FLOOR LEVEL

13- WINDOW LABEL

14- DOOR LABEL

15- DETAILS SIGN

16- STRUCTURAL SYMBOLS - COLUMNS

1- EXISTING COLUMN

2- RC COLUMN

3- COLUMN CONCRETE JACKETING

4- COLUMN STEEL JACKETING

* REF TO STRUCTURE DRAWINGS TO GET FINAL DATA

PROJECT TITLE

PRODUCTIVITY& URBAN RENEWAL
IN EAST JERUSALEM (PURE)

RENOVATION WORKS OF
BUILDING SS004

SHEET TITLE:

First Floor Plan

CONSULTANTS:



ZIADAH
ARCHITECTS & ENGINEERS
معماريون ومهندسون



DOUR
ENGINEERING & PLANNING
CONSULTING ENGINEERS

Scale :
1:100 When Printed At Sheet (A1)

 
Date :
16 September 2017

Design by :
ZIADAH CONSULTANTS

checked by:
ZIADAH CONSULTANTS

Drawn by:
ZIADAH CONSULTANTS


Project No. :
21/16




0 10 20 30

Division :
ARCHITECTURAL

SHEET NO.
A1-03

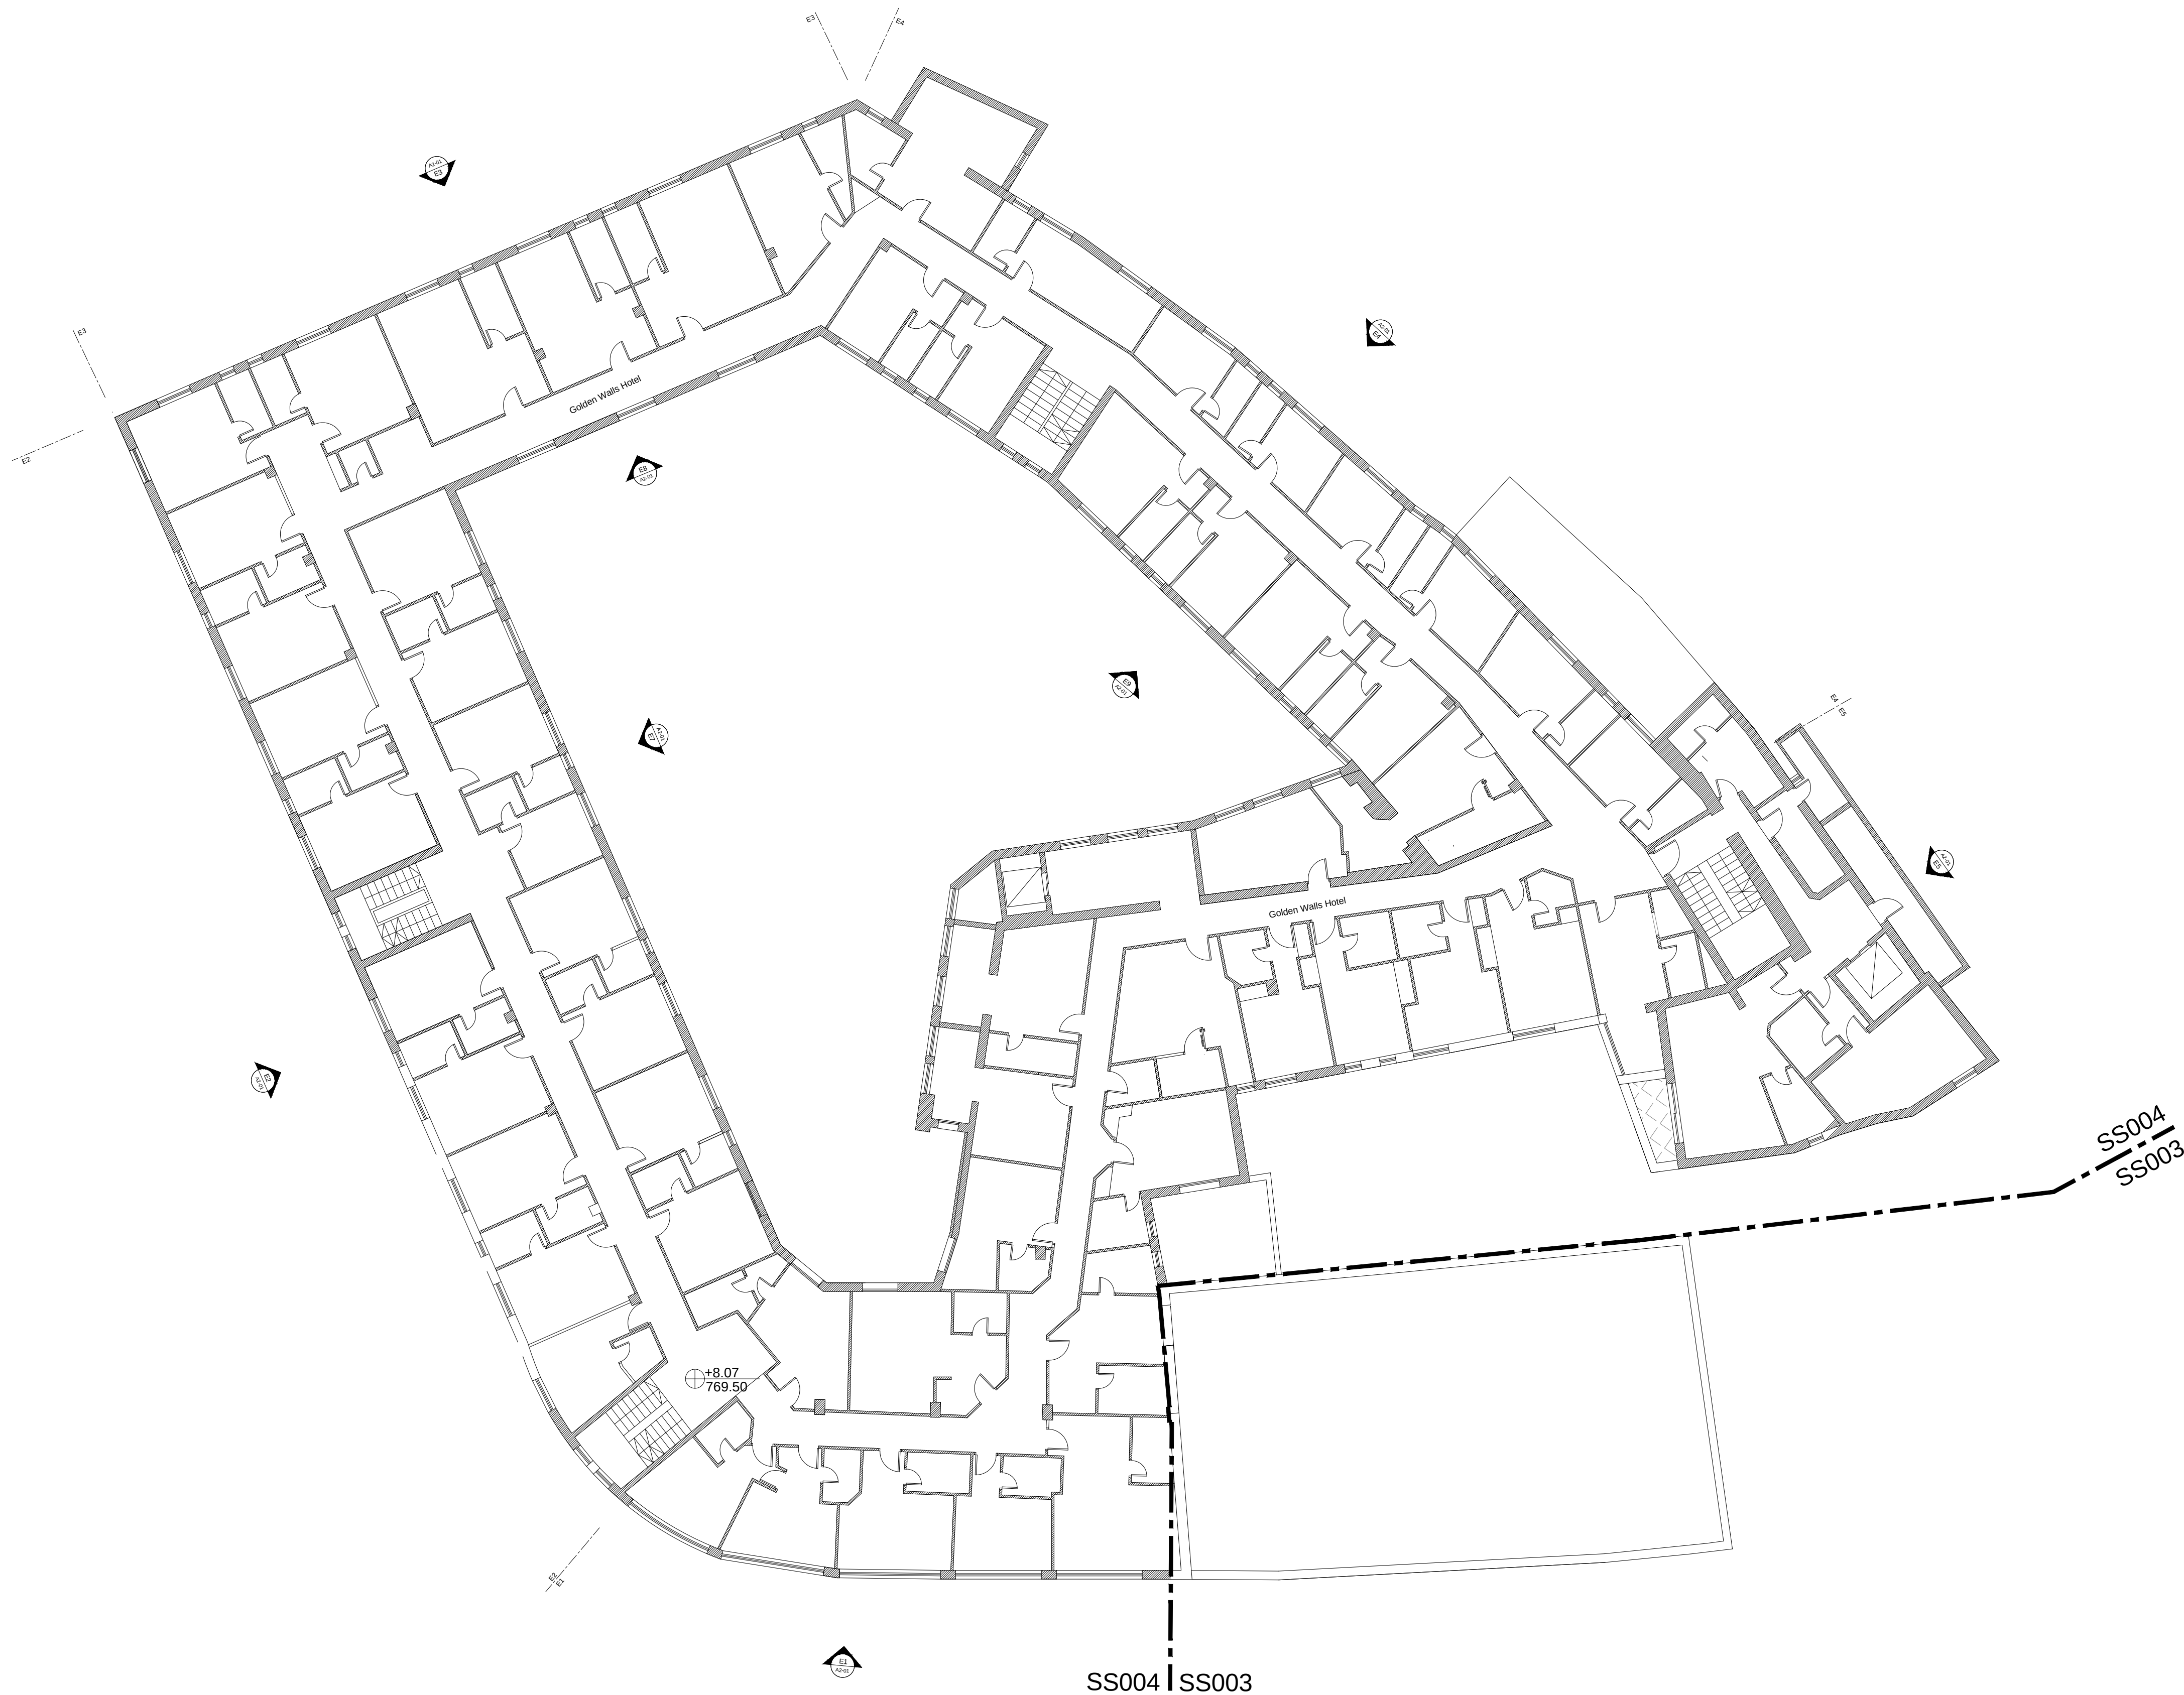

دائرة الأوقاف الإسلامية في القدس

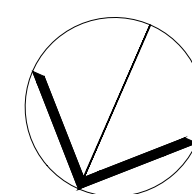

NORTH

03			
02			
01			
REV.	SUBJECT	DATE	BY

NOTES:
- All Levels in meter
- All dimensions are shown in centimeters.


LEGEND:	
1- REINFORCED CONCRETE	
2- CONCRETE	
3- STONE	
4- CONCRETE BLOCK	
5- YTONG BLOCK	
5- BASE COURSE	
6- SAND	
7- COMPACTED FILL OR NATURAL GROUND	
8- LEVEL SYMBOL (PLAN)	
10- LEVEL SYMBOL (SECTION - ELEVATION)	
11- FINISH FLOOR LEVEL	
12- CONCRETE FLOOR LEVEL	
13- WINDOW LABEL	
14- DOOR LABEL	
15- DETAILS SIGN	
16- STRUCTURAL SYMBOLS - COLUMNS	
1- EXISTING COLUMN	
2- RC COLUMN	
3- COLUMN CONCRETE JACKETING	
4- COLUMN STEEL JACKETING	
* REF TO STRUCTURE DRAWINGS TO GET FINAL DATA	

PROJECT TITLE
PRODUCTIVITY& URBAN RENEWAL
IN EAST JERUSALEM (PURE)
RENOVATION WORKS OF
BUILDING SS004


SHEET TITLE:
Second Floor Plan

CONSULTANTS:
ZIADAH
ARCHITECTS & ENGINEERS
معماريون ومهندسون
DOUR
ENGINEERING & PLANNING
CONSULTING ENGINEERS

Scale : 1:100 When Printed At Sheet (A1)	Date : 16 September 2017
Design by : ZIADAH CONSULTANTS	
checked by : ZIADAH CONSULTANTS	Division : ARCHITECTURAL
Drawn by : ZIADAH CONSULTANTS	SHEET NO. A1-04
Project No. 21/16	

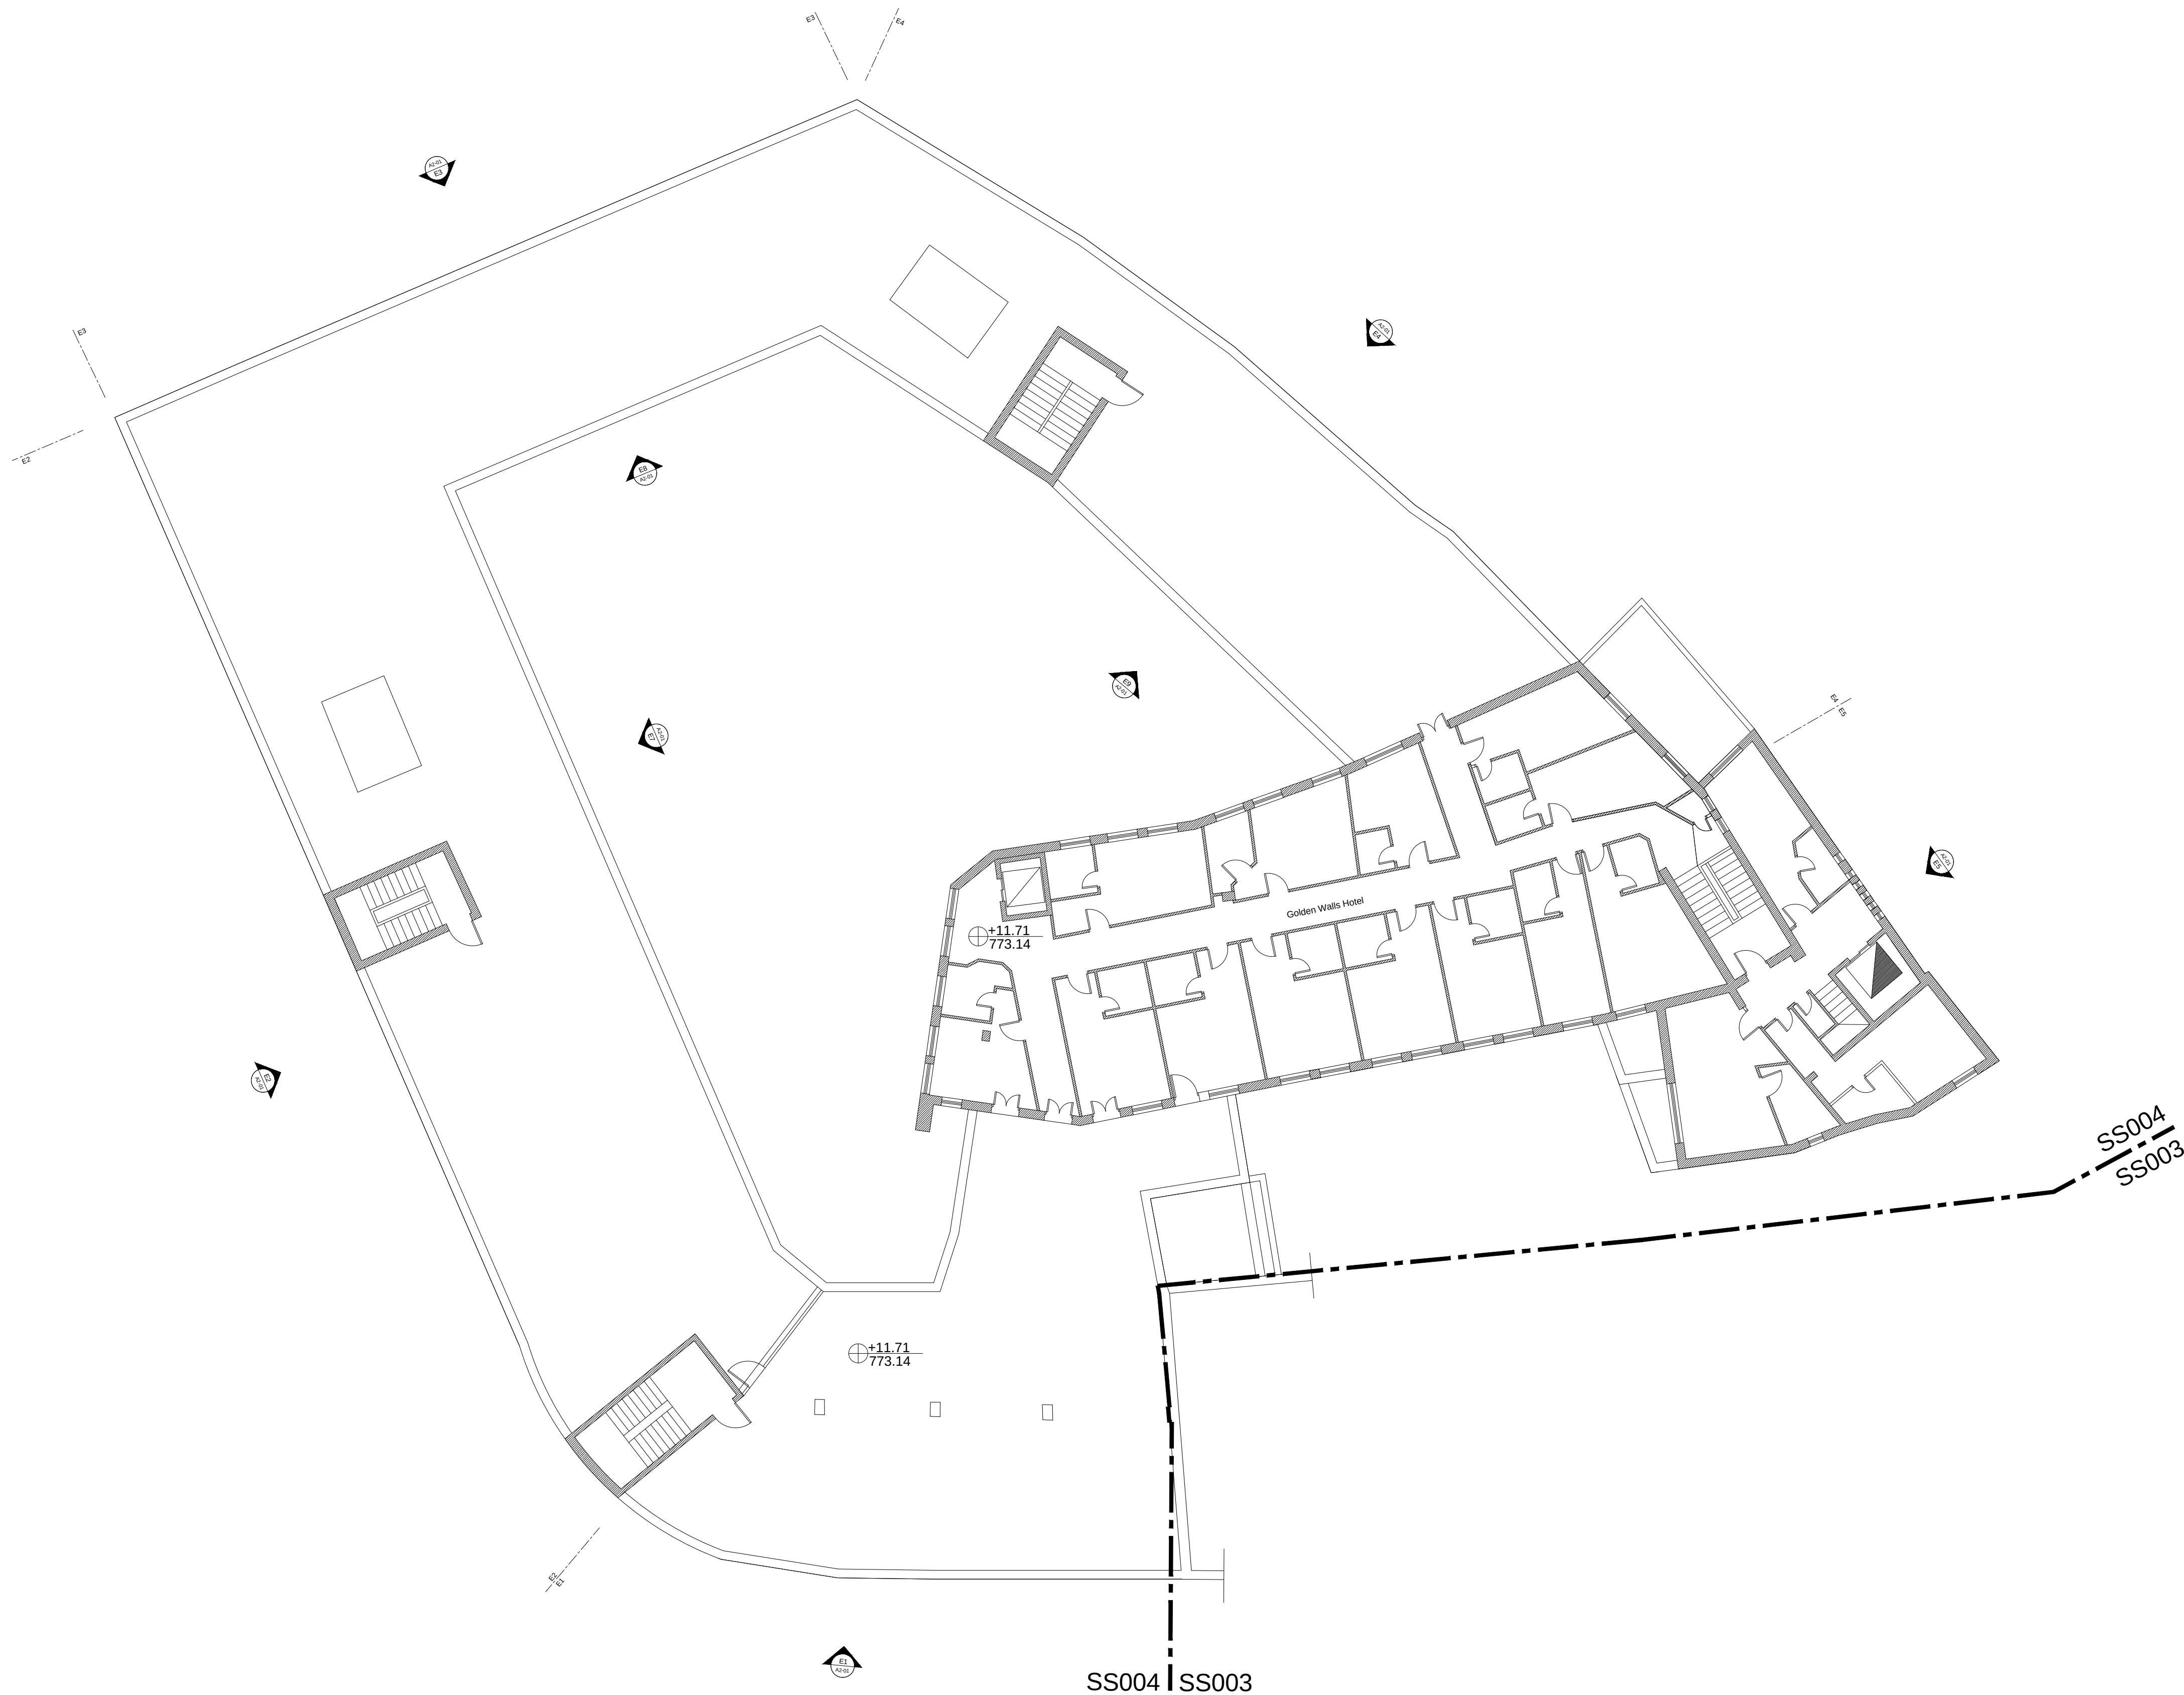

دائرة الأوقاف الإسلامية في القدس

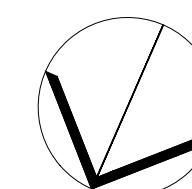

NORTH

03			
02			
01			
REV.	SUBJECT	DATE	BY

NOTES:
- All Levels in meter
- All dimensions are shown in centimeters.


LEGEND:	
1- REINFORCED CONCRETE	
2- CONCRETE	
3- STONE	
4- CONCRETE BLOCK	
5- YTONG BLOCK	
6- BASE COURSE	
7- SAND	
8- COMPACTED FILL OR NATURAL GROUND	
9- LEVEL SYMBOL (PLAN)	
10- LEVEL SYMBOL (SECTION - ELEVATION)	
11- FINISH FLOOR LEVEL	
12- CONCRETE FLOOR LEVEL	
13- WINDOW LABEL	
14- DOOR LABEL	
15- DETAILS SIGN	
16- STRUCTURAL SYMBOLS - COLUMNS	
1- EXISTING COLUMN	
2- RC COLUMN	
3- COLUMN CONCRETE JACKETING	
4- COLUMN STEEL JACKETING	
* REF TO STRUCTURE DRAWINGS TO GET FINAL DATA	

PROJECT TITLE
PRODUCTIVITY& URBAN RENEWAL
IN EAST JERUSALEM (PURE)
RENOVATION WORKS OF
BUILDING SS004


SHEET TITLE:
Roof Floor Plan

CONSULTANTS:
ZIADAH
ARCHITECTS & ENGINEERS
معماريون ومهندسون
DOUR
ENGINEERING & PLANNING
CONSULTING ENGINEERS

Scale : 1:100 When Printed At Sheet (A1)	Date : 16 September 2017
Design by : ZIADAH CONSULTANTS	
checked by: ZIADAH CONSULTANTS	Division : ARCHITECTURAL
Drawn by: ZIADAH CONSULTANTS	SHEET NO. A1-05
Project No. 21/16	

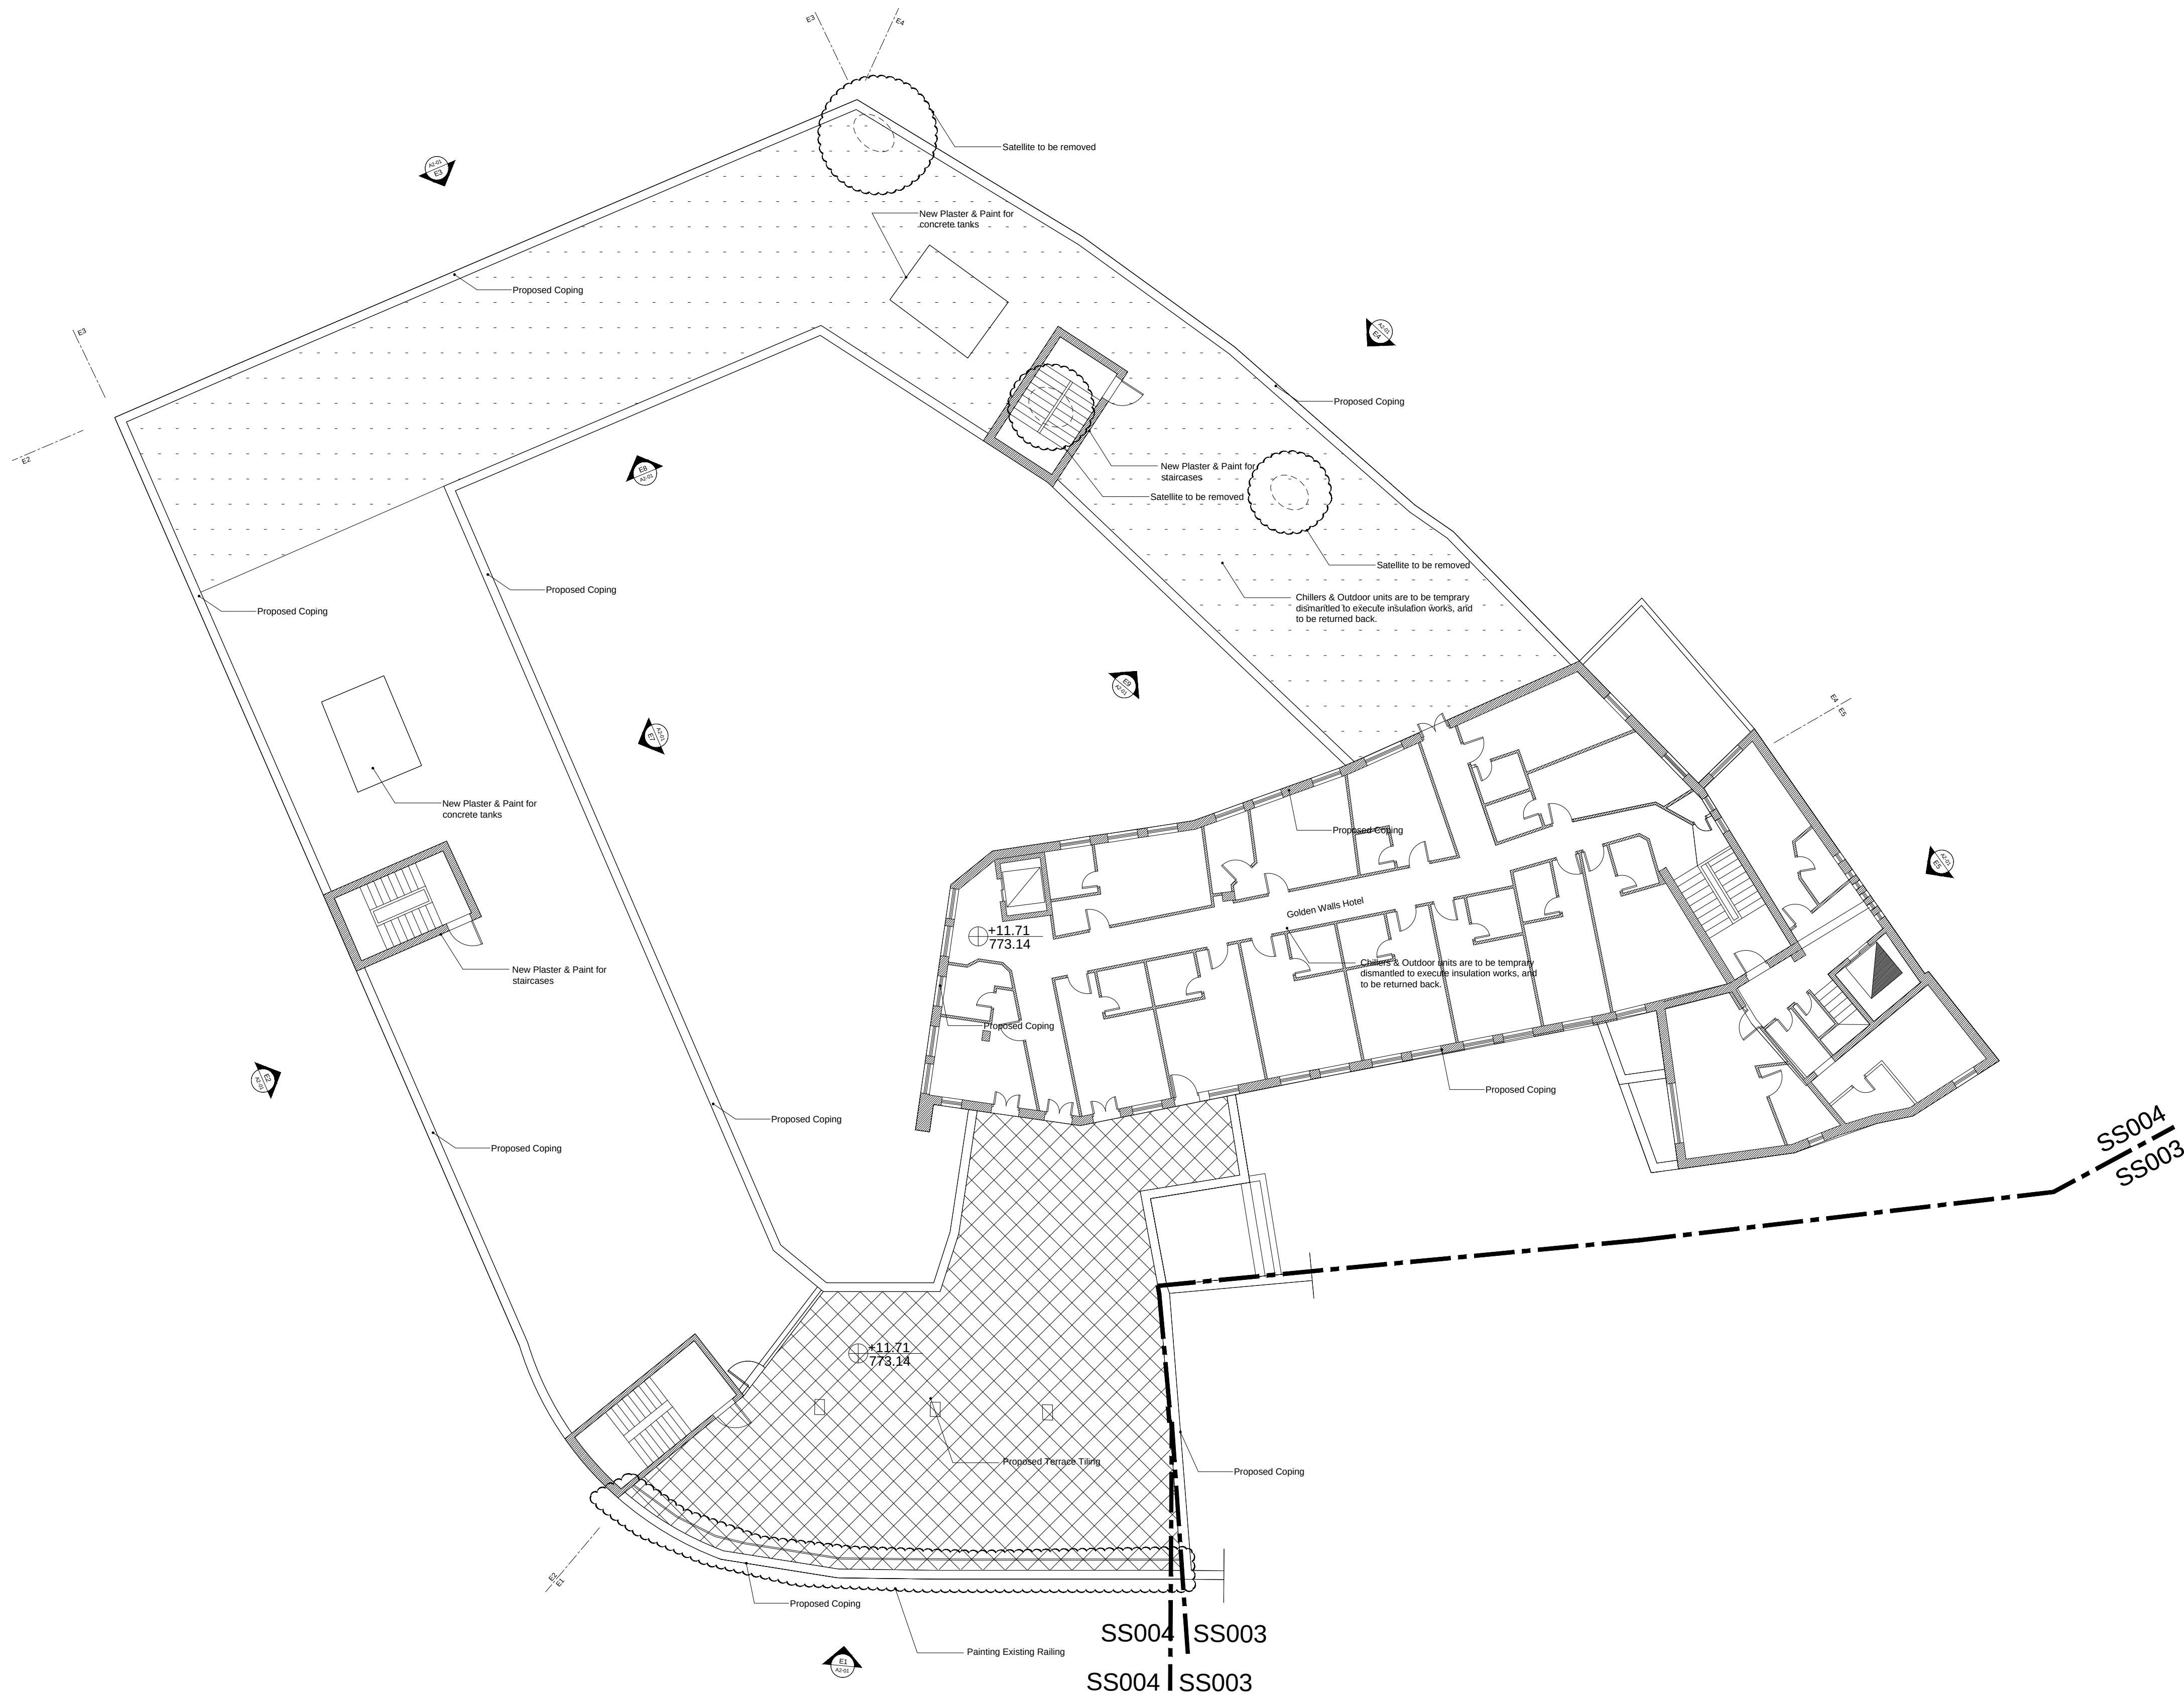

دائرة الأوقاف الإسلامية في القدس

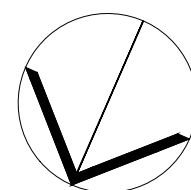

NORTH

REV.	SUBJECT	DATE	BY
03			
02			
01			

NOTES:
- All Levels in meter
- All dimensions are shown in centimeters.


LEGEND:	
1- REINFORCED CONCRETE	
2- CONCRETE	
3- STONE	
4- CONCRETE BLOCK	
5- YTONG BLOCK	
6- SAND	
7- COMPACTED FILL OR NATURAL GROUND	
8- LEVEL SYMBOL (PLAN)	
10- LEVEL SYMBOL (SECTION - ELEVATION)	
11- FINISH FLOOR LEVEL	
12- CONCRETE FLOOR LEVEL	
13- WINDOW LABEL	
14- DOOR LABEL	
15- DETAILS SIGN	
16- STRUCTURAL SYMBOLS - COLUMNS	
1- EXISTING COLUMN	
2- RC COLUMN	
3- COLUMN CONCRETE JACKETING	
4- COLUMN STEEL JACKETING	
* REF TO STRUCTURE DRAWINGS TO GET FINAL DATA	

PROJECT TITLE
PRODUCTIVITY& URBAN RENEWAL
IN EAST JERUSALEM (PURE)
RENOVATION WORKS OF
BUILDING SS004


SHEET TITLE:
**Roof Floor
Interventions Plan**

CONSULTANTS:
ZIADAH
ARCHITECTS & ENGINEERS
مهندسون وعلماء
DOUR
ENGINEERING & PLANNING
CONSULTING ENGINEERS

Scale : 1:100 When Printed At Sheet (A1)	Date : 16 September 2017
Design by : ZIADAH CONSULTANTS	
checked by : ZIADAH CONSULTANTS	Division : ARCHITECTURAL
Drawn by : ZIADAH CONSULTANTS	SHEET NO. A1-06
Project No. : 21/16	

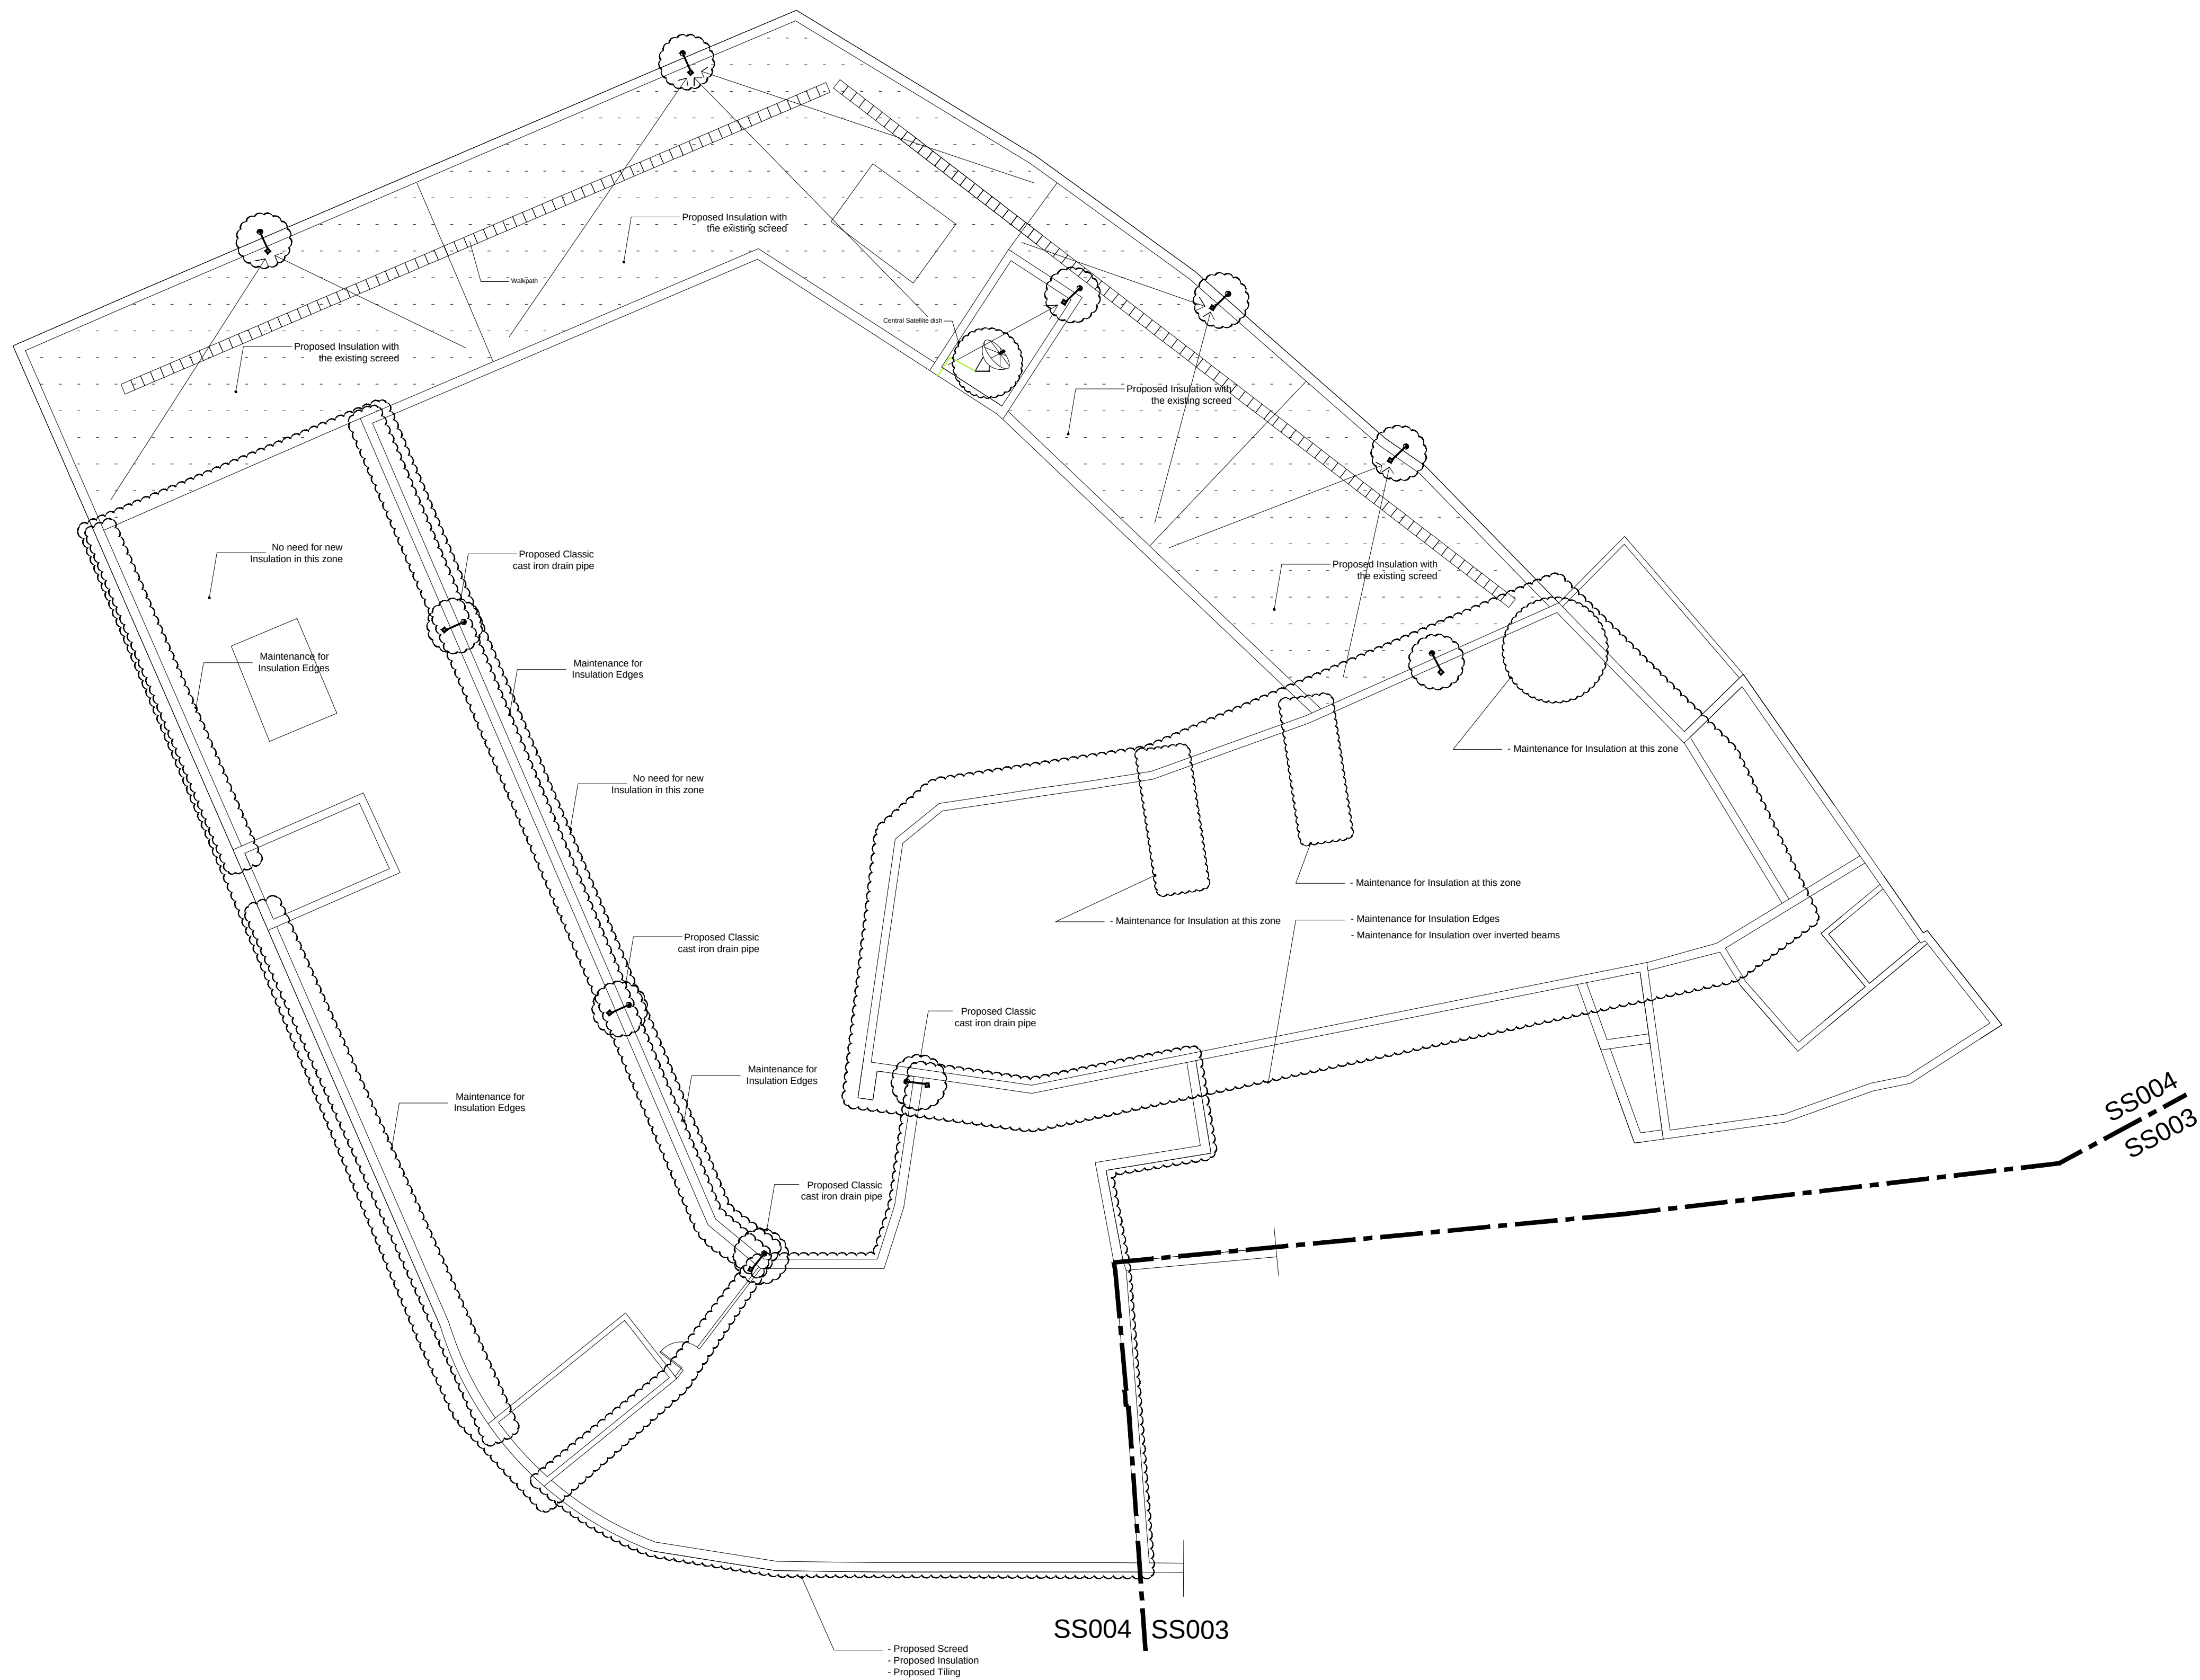

دائرة الأوقاف الإسلامية في القدس

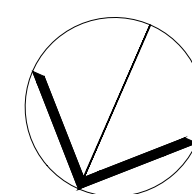

03			
02			
01			
REV.	SUBJECT	DATE	BY

NOTES:
- All Levels in meter
- All dimensions are shown in centimeters.


1-	REINFORCED CONCRETE	
2-	CONCRETE	
3-	STONE	
4-	CONCRETE BLOCK	
5-	YTONG BLOCK	
6-	SAND	
7-	COMPACTED FILL OR NATURAL GROUND	
8-	LEVEL SYMBOL (PLAN)	
10-	LEVEL SYMBOL (SECTION - ELEVATION)	
11-	FINISH FLOOR LEVEL	
12-	CONCRETE FLOOR LEVEL	
13-	WINDOW LABEL	
14-	DOOR LABEL	
15-	DETAILS SIGN	
16-	STRUCTURAL SYMBOLS - COLUMNS	
1-	EXISTING COLUMN	
2-	RC COLUMN	
3-	COLUMN CONCRETE JACKETING	
4-	COLUMN STEEL JACKETING	

PROJECT TITLE
PRODUCTIVITY& URBAN RENEWAL
IN EAST JERUSALEM (PURE)
RENOVATION WORKS OF
BUILDING SS004

SHEET TITLE:
Roof Drainage Plan

CONSULTANTS:
ZIADAH
ARCHITECTS & ENGINEERS
مهندسون معماريون ومهندسون
DOUR
ENGINEERING & PLANNING
CONSULTING ENGINEERS

Scale : 1:100 When Printed At Sheet (A1)	Date : 16 September 2017
Design by : ZIADAH CONSULTANTS	Division : ARCHITECTURAL
checked by : ZIADAH CONSULTANTS	SHEET NO. A1-07
Drawn by : ZIADAH CONSULTANTS	
Project No. : 21/16	

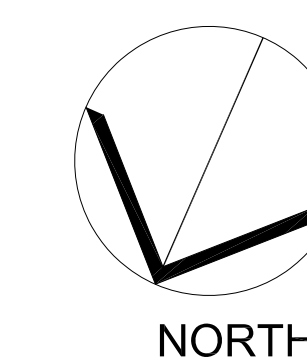

03			
02			
01			
REV.	SUBJECT	DATE	BY

NOTES:
- All Levels in meter
- All dimensions are shown in centimeters.

LEGEND:


1- REINFORCED CONCRETE	
2- CONCRETE	
3- STONE	
4- CONCRETE BLOCK	
5- YONG BLOCK	
6- SAND	
7- COMPACTED FILL OR NATURAL GROUND	
8- LEVEL SYMBOL (PLAN)	
10- LEVEL SYMBOL (SECTION - ELEVATION)	
11- FINISH FLOOR LEVEL	
12- CONCRETE FLOOR LEVEL	
13- WINDOW LABEL	
14- DOOR LABEL	
15- DETAILS SIGN	
16- STRUCTURAL SYMBOLS - COLUMNS	
1- EXISTING COLUMN	
2- RC COLUMN	
3- COLUMN CONCRETE JACKETING	
4- COLUMN STEEL JACKETING	
* REF TO STRUCTURE DRAWINGS TO GET FINAL DATA	

PROJECT TITLE
PRODUCTIVITY& URBAN RENEWAL
IN EAST JERUSALEM (PURE)
RENOVATION WORKS OF
BUILDING SS004

SHEET TITLE:
Elevations (1) & (2)

CONSULTANTS:
ZIADAH
ARCHITECTS & ENGINEERS
مهندسين معماريين ومهندسين
DOOR
ENGINEERING & PLANNING
CONSULTING ENGINEERS


Scale :
1:100 When Printed At Sheet (A1)
Design by :
ZIADAH CONSULTANTS
checked by :
ZIADAH CONSULTANTS
Drawn by :
ZIADAH CONSULTANTS
Project No. : 21/16
Date :
16 September 2017
Division :
ARCHITECTURAL
SHEET NO.
A2-01

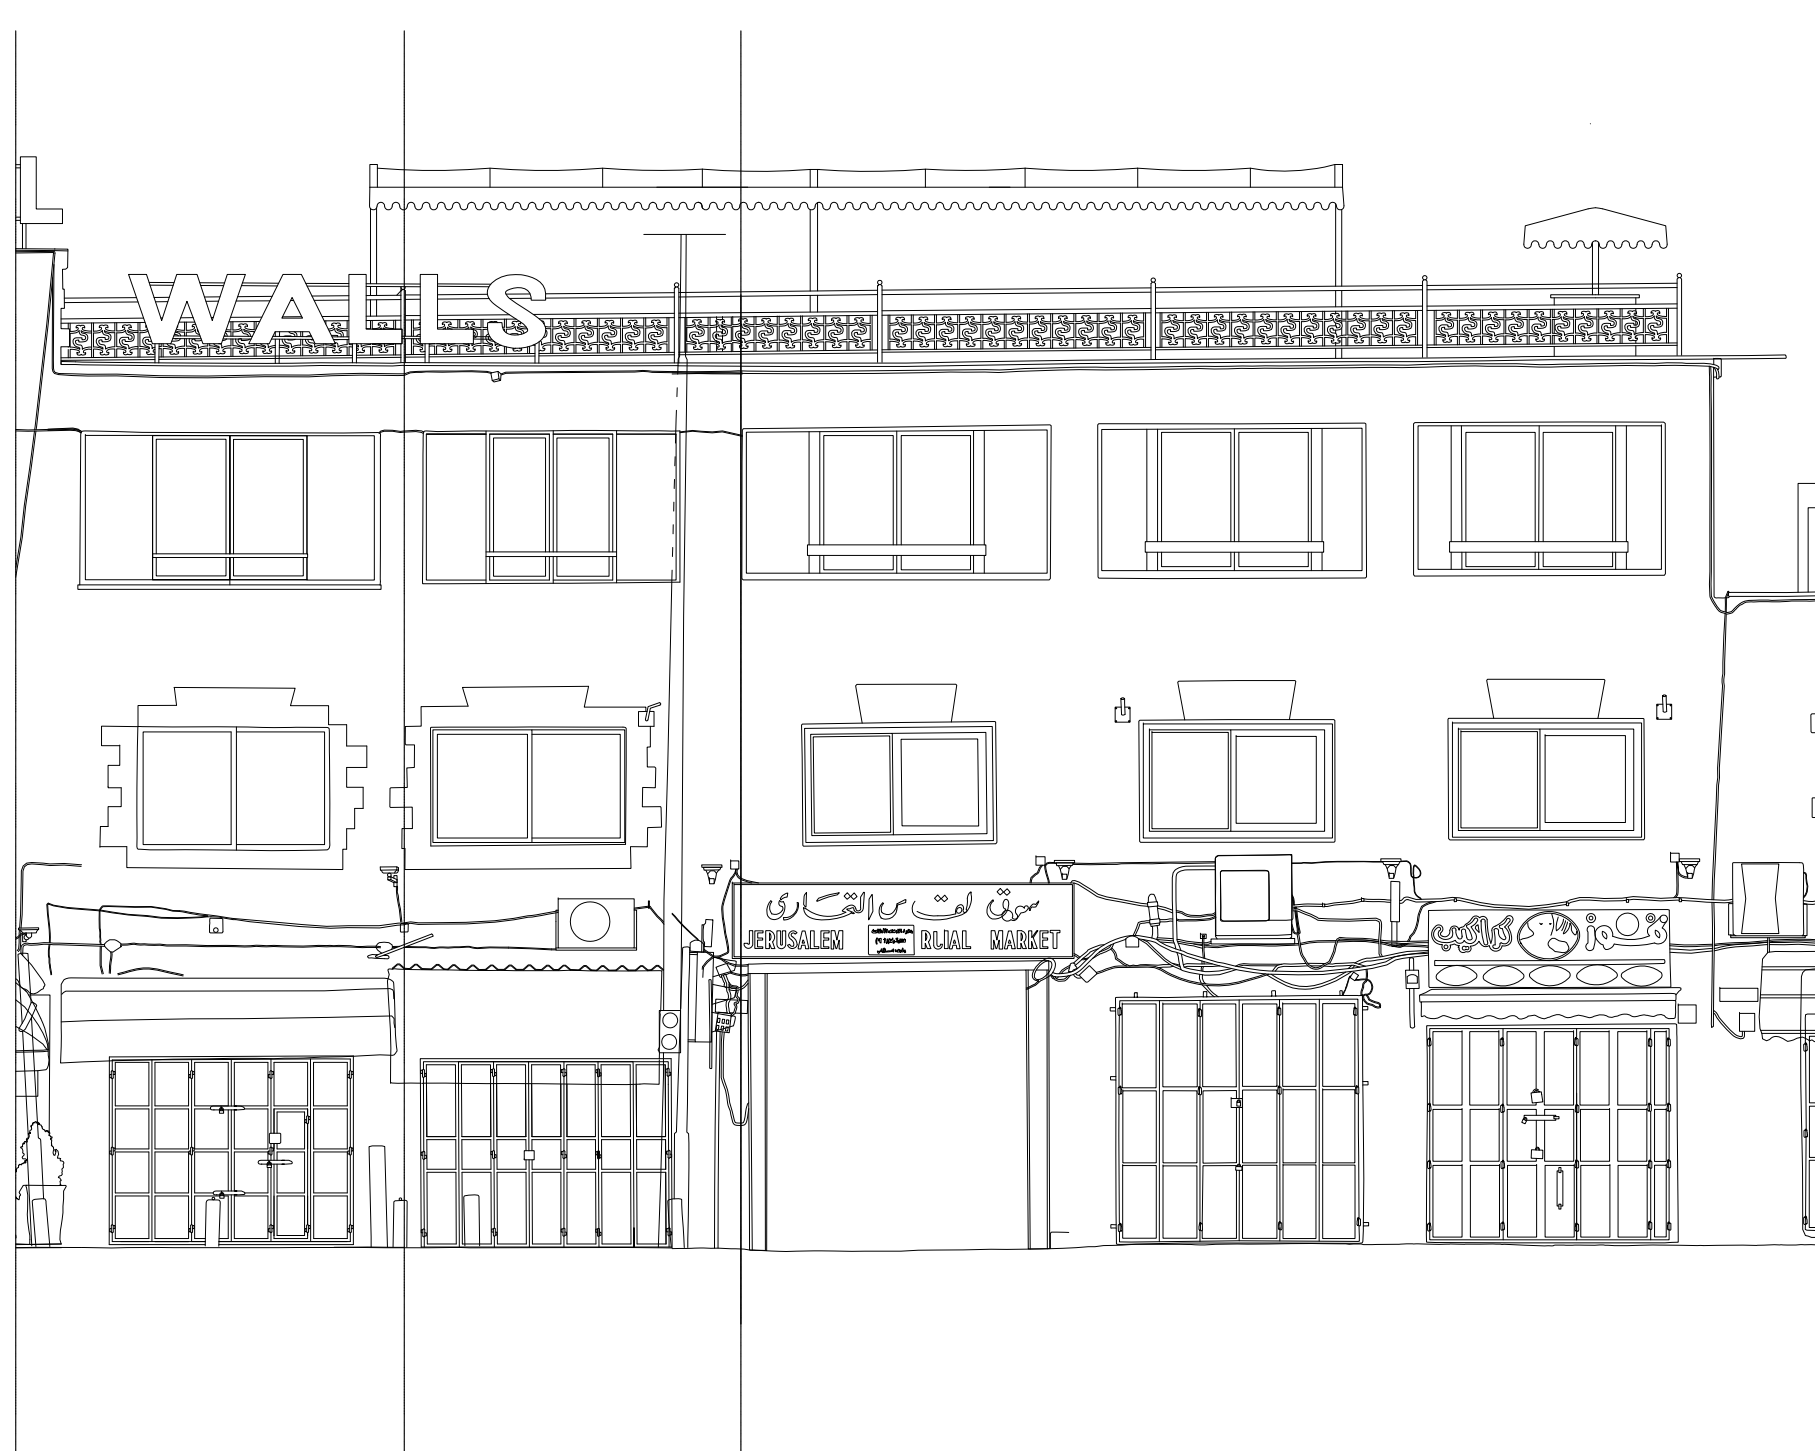

1 ELEVATION (1) / EXISTING
1:100




3 ELEVATION (2) / EXISTING
1:100

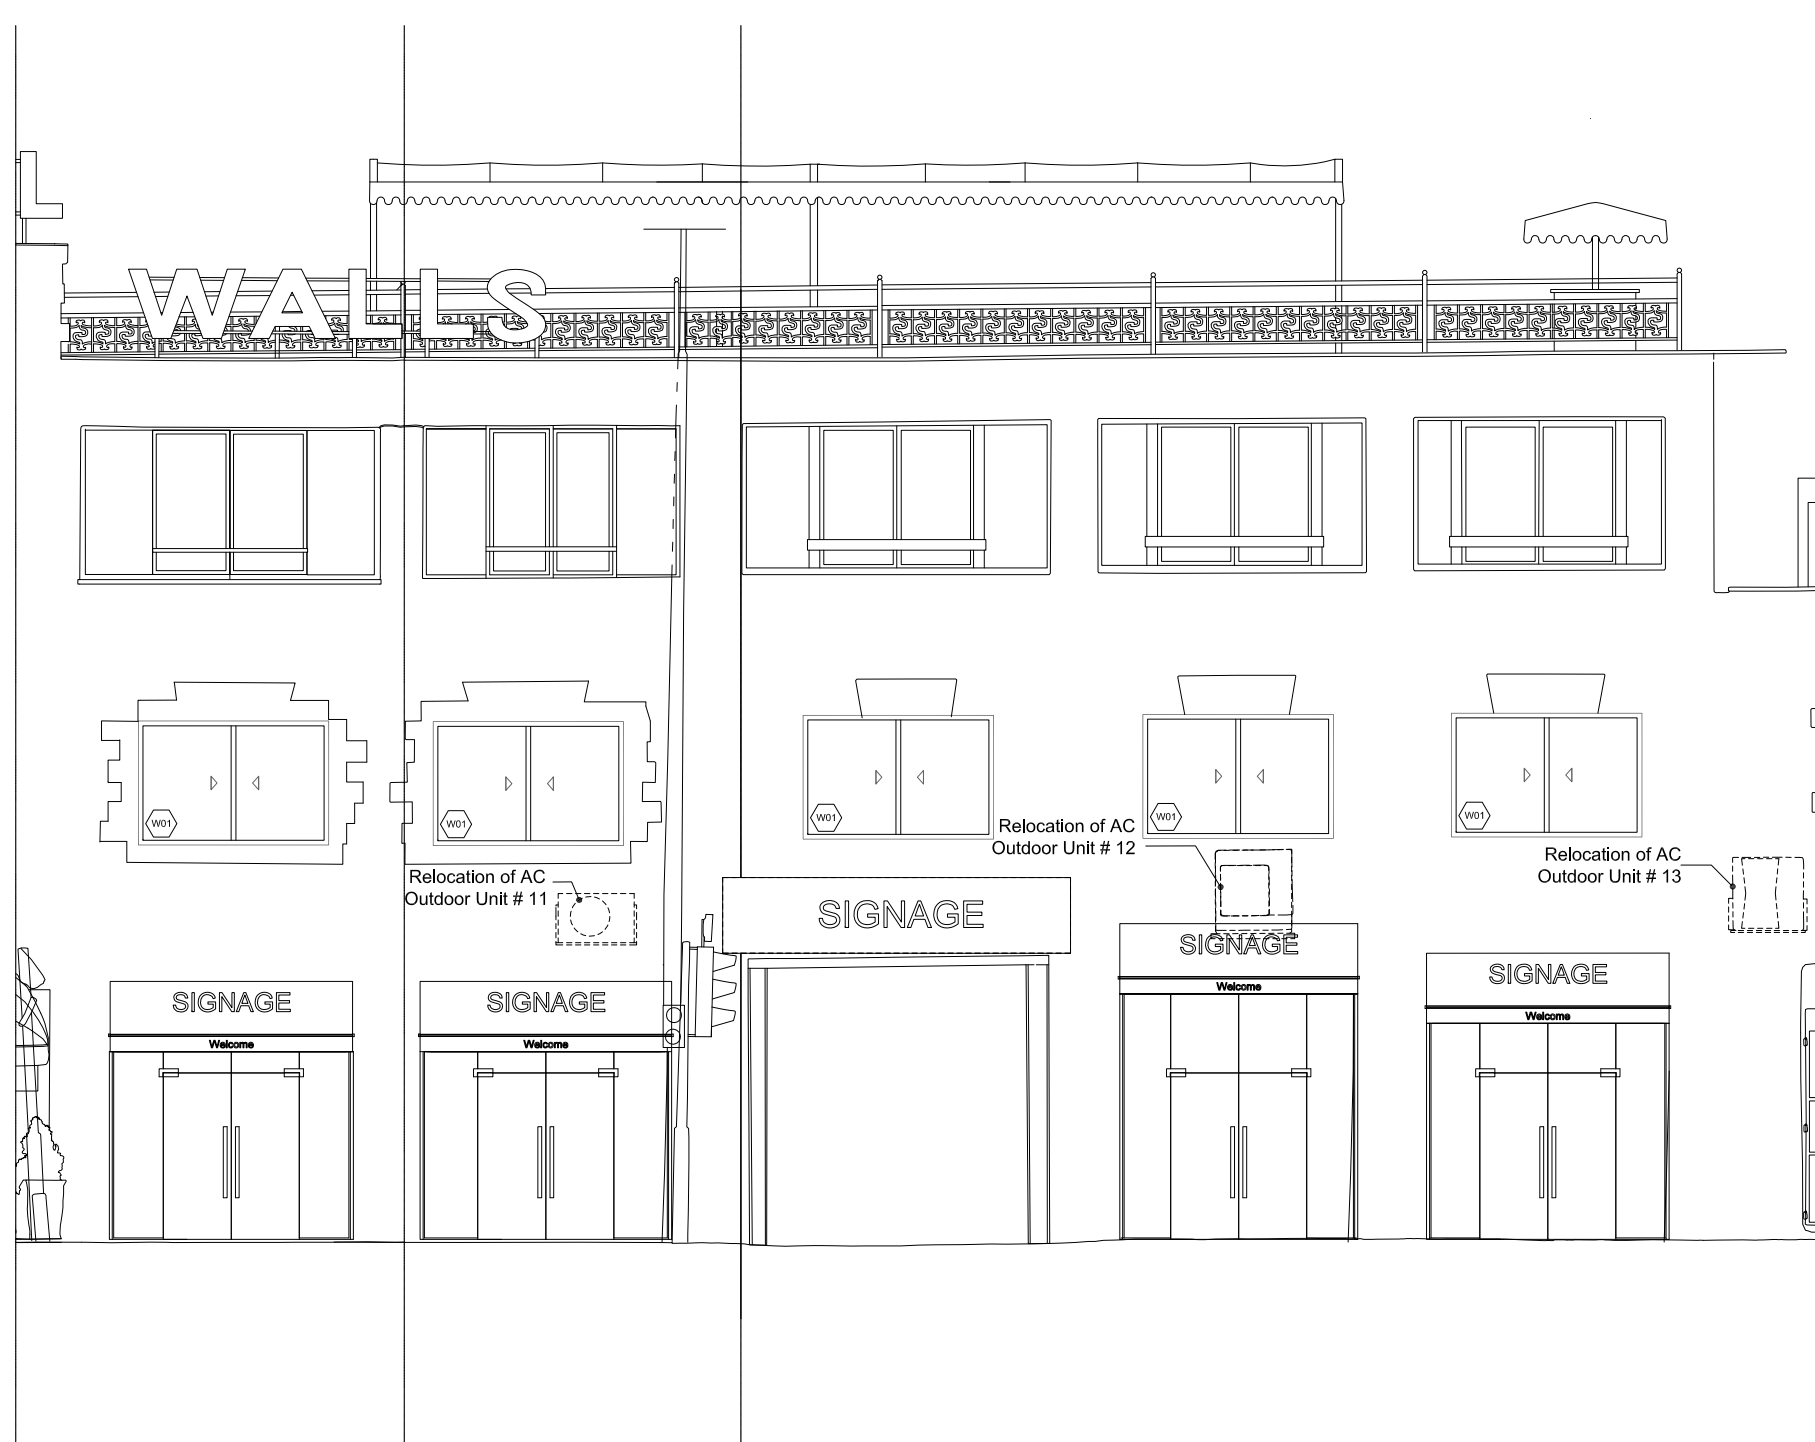

2 ELEVATION (1) / Interventions
1:100



4 ELEVATION (2) / Interventions
1:100

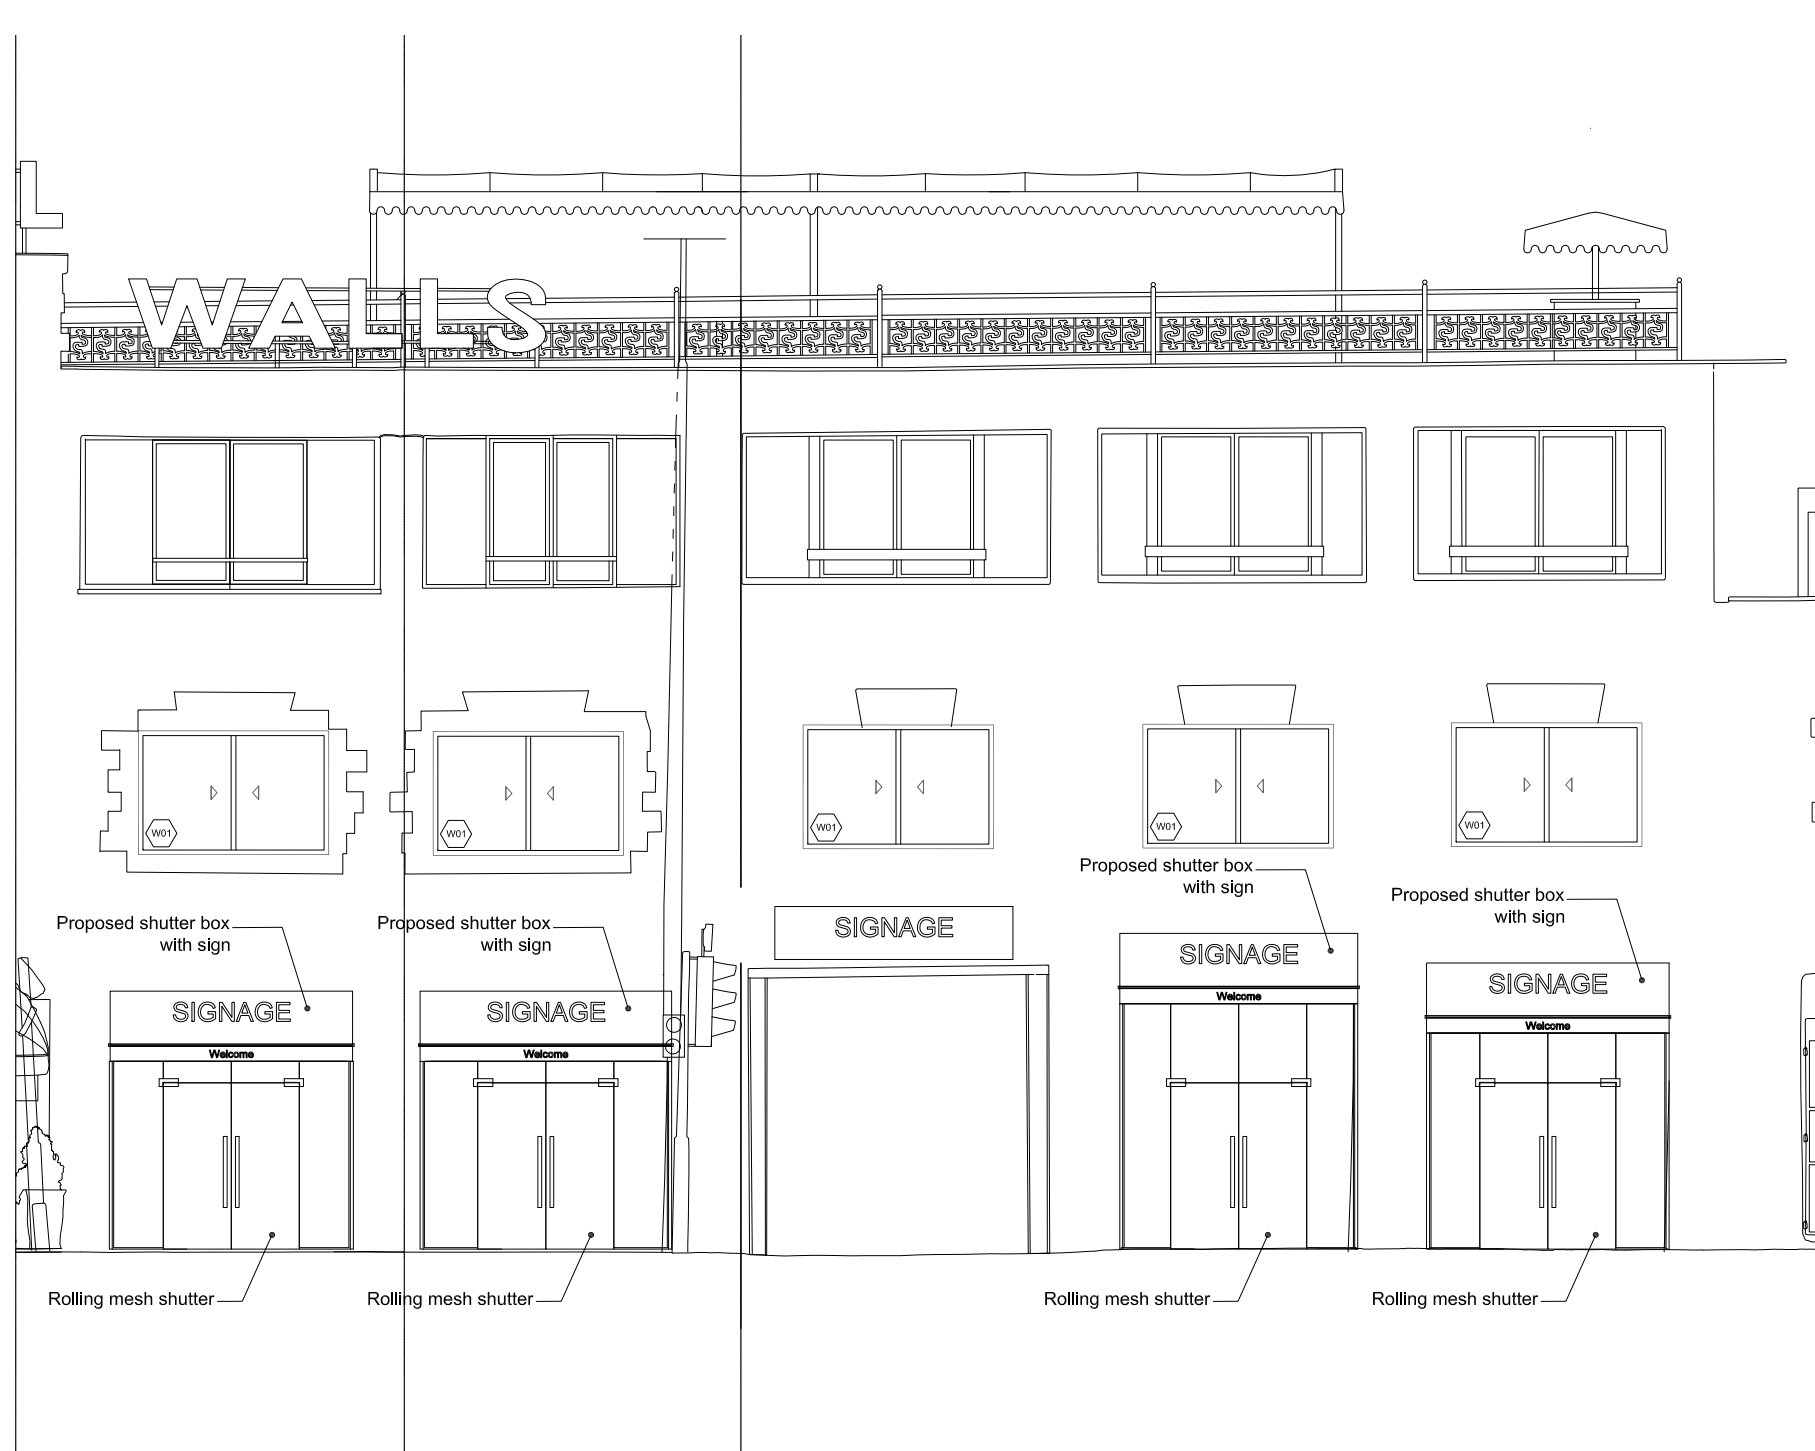

2 ELEVATION (1) / Proposed
1:100



4 ELEVATION (2) / Proposed
1:100




1 ELEVATION (3) / EXISTING
1:100




2 ELEVATION (3) / Interventions
1:100




2 ELEVATION (3) / Proposed
1:100

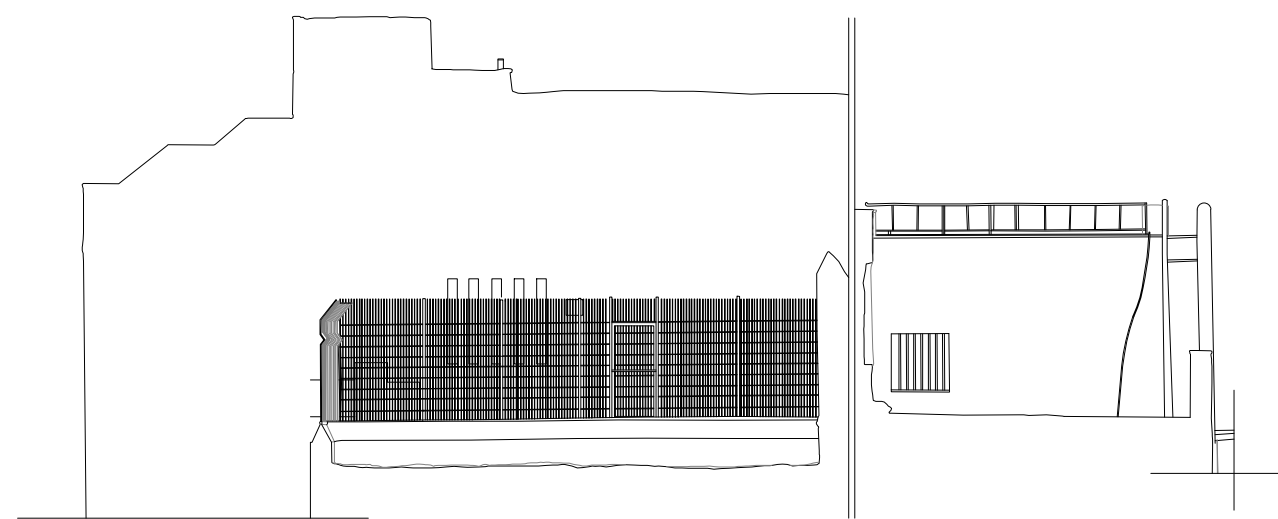

3 ELEVATION (4) / EXISTING
1:100

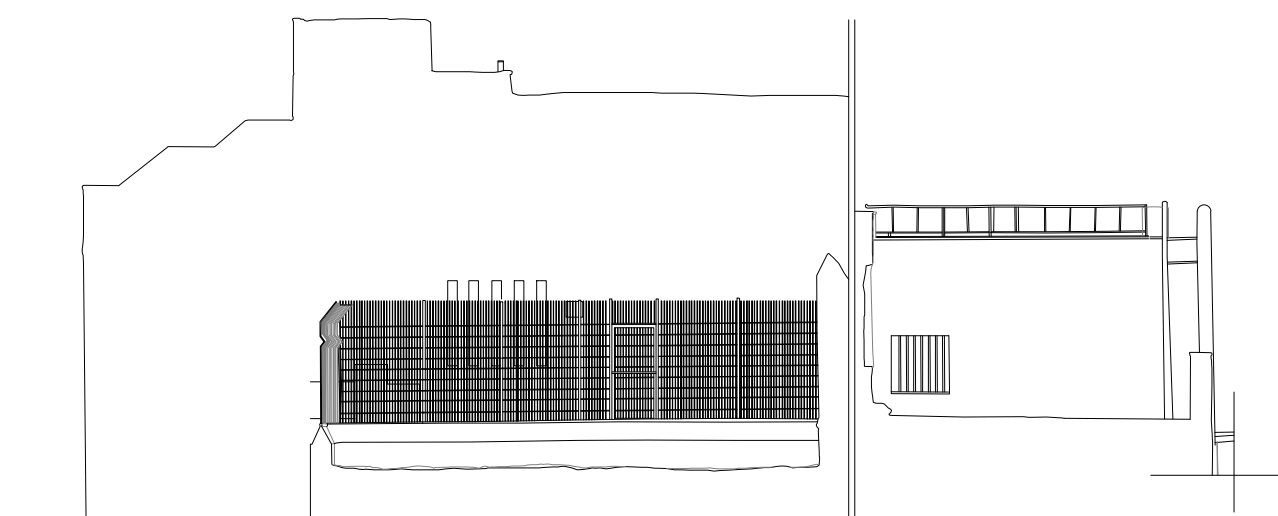


4 ELEVATION (4) / Interventions
1:100

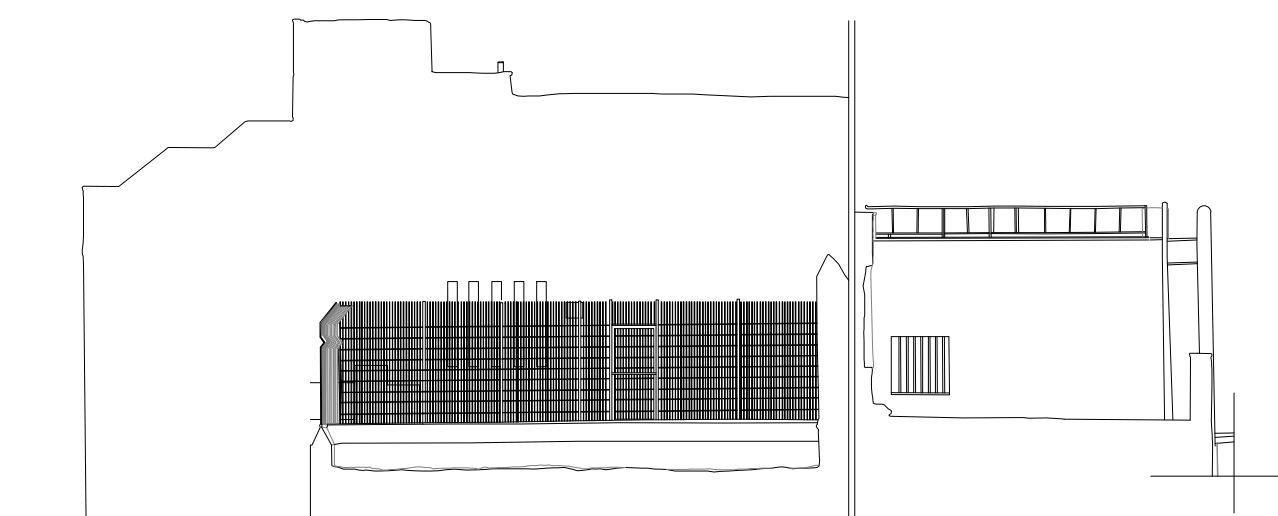

4 ELEVATION (4) / Proposed
1:100

دائرة الأوقاف الإسلامية في القدس

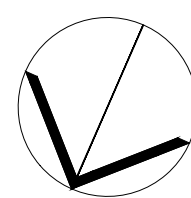

NORTH

03			
02			
01			
REV.	SUBJECT	DATE	BY

NOTES:
- All Levels in meter
- All dimensions are shown in centimeters.

LEGEND:	
1- REINFORCED CONCRETE	
2- CONCRETE	
3- STONE	
4- CONCRETE BLOCK	
5- YTONG BLOCK	
5- BASE COURSE	
6- SAND	
7- COMPACTED FILL OR NATURAL GROUND	
8- LEVEL SYMBOL (PLAN)	
10- LEVEL SYMBOL (SECTION - ELEVATION)	
11- FINISH FLOOR LEVEL	
12- CONCRETE FLOOR LEVEL	
13- WINDOW LABEL	
14- DOOR LABEL	
15- DETAILS SIGN	
16- STRUCTURAL SYMBOLS - COLUMNS	
1- EXISTING COLUMN	
2- RC COLUMN	
3- COLUMN CONCRETE JACKETING	
4- COLUMN STEEL JACKETING	
* REF TO STRUCTURE DRAWINGS TO GET FINAL DATA	

PROJECT TITLE
PRODUCTIVITY& URBAN RENEWAL
IN EAST JERUSALEM (PURE)
RENOVATION WORKS OF
BUILDING SS004

SHEET TITLE:
Elevations (3) & (4)

CONSULTANTS:
ZIADAH
ARCHITECTS & ENGINEERS
معماريون ومهندسون
DOUR
ENGINEERING & PLANNING
CONSULTING ENGINEERS


Scale : 1:100 When Printed At Sheet (A1)	Date : 16 September 2017
Design by : ZIADAH CONSULTANTS	
checked by : ZIADAH CONSULTANTS	Division : ARCHITECTURAL
Drawn by : ZIADAH CONSULTANTS	SHEET NO. A2-02
Project No. 21/16	




1 ELEVATION (5) / EXISTING
1:100




2 ELEVATION (5) / Interventions
1:100

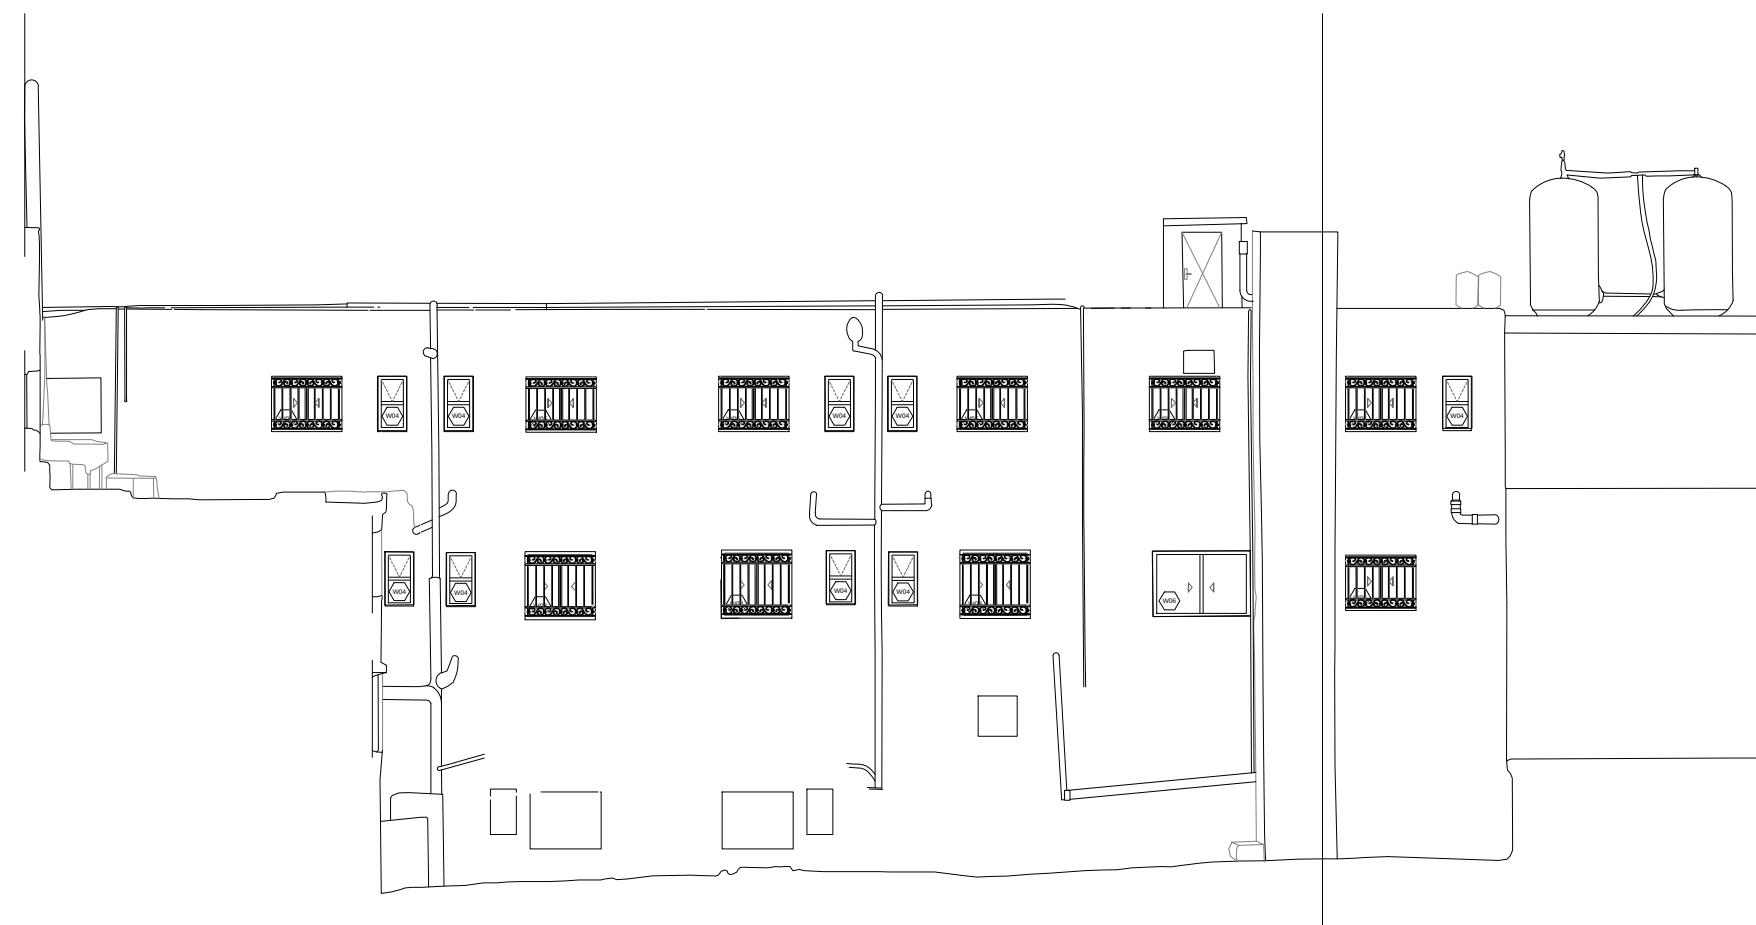


2 ELEVATION (5) / Proposed
1:100

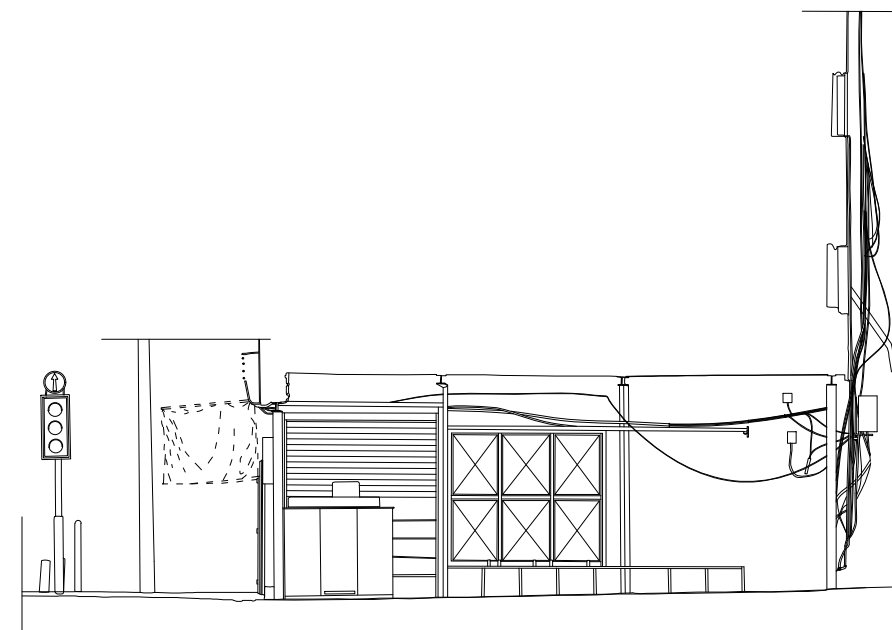

3 ELEVATION (6) / EXISTING
1:100

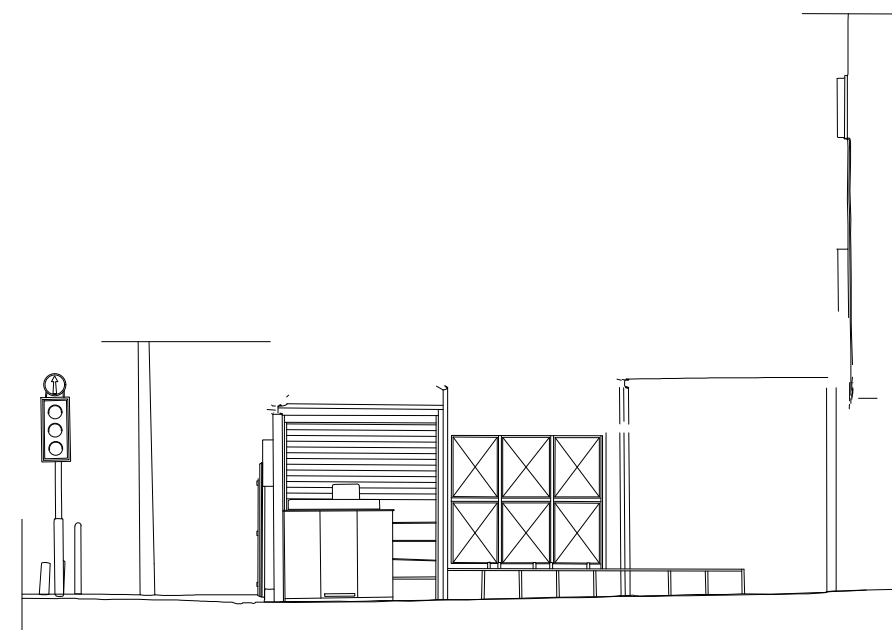


4 ELEVATION (6) / Interventions
1:100

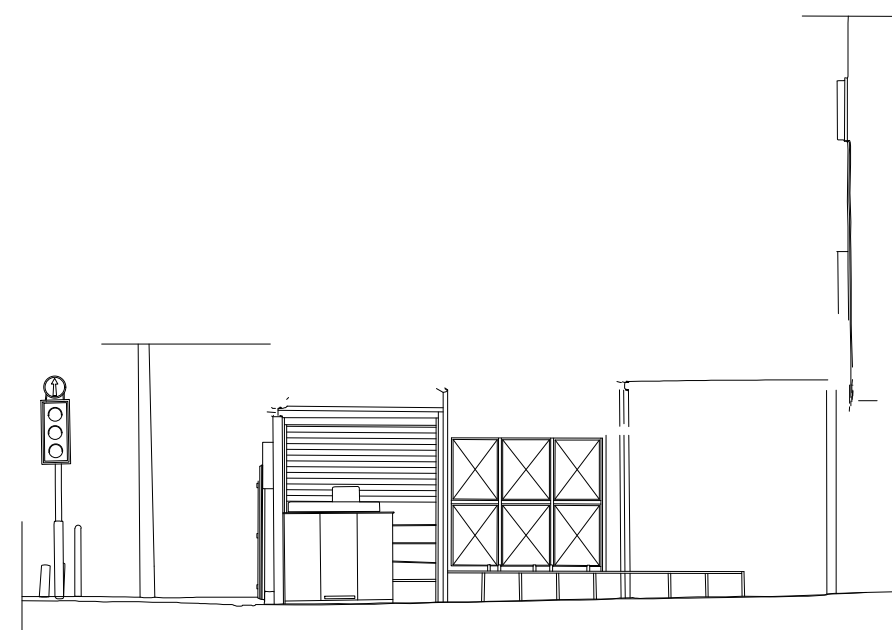

4 ELEVATION (6) / Proposed
1:100

دائرة الأوقاف الإسلامية في القدس

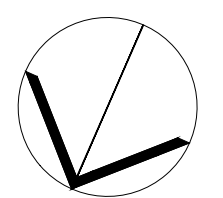

NORTH

03			
02			
01			
REV.	SUBJECT	DATE	BY

NOTES:
- All Levels in meter
- All dimensions are shown in centimeters.

LEGEND:	
1- REINFORCED CONCRETE	
2- CONCRETE	
3- STONE	
4- CONCRETE BLOCK	
5- YTONG BLOCK	
5- BASE COURSE	
6- SAND	
7- COMPACTED FILL OR NATURAL GROUND	
8- LEVEL SYMBOL (PLAN)	
10- LEVEL SYMBOL (SECTION - ELEVATION)	
11- FINISH FLOOR LEVEL	
12- CONCRETE FLOOR LEVEL	
13- WINDOW LABEL	
14- DOOR LABEL	
15- DETAILS SIGN	
16- STRUCTURAL SYMBOLS - COLUMNS	
1- EXISTING COLUMN	
2- RC COLUMN	
3- COLUMN CONCRETE JACKETING	
4- COLUMN STEEL JACKETING	
* REF TO STRUCTURE DRAWINGS TO GET FINAL DATA	

PROJECT TITLE
PRODUCTIVITY& URBAN RENEWAL
IN EAST JERUSALEM (PURE)
RENOVATION WORKS OF
BUILDING SS004

SHEET TITLE:
Elevations (5) & (6)

CONSULTANTS:
ZIADAH
ARCHITECTS & ENGINEERS
معماريون ومهندسون
DOUR
ENGINEERING & PLANNING
CONSULTING ENGINEERS

Scale : 1:100 When Printed At Sheet (A1)	Date : 16 September 2017
Design by : ZIADAH CONSULTANTS	
checked by : ZIADAH CONSULTANTS	Division : ARCHITECTURAL
Drawn by : ZIADAH CONSULTANTS	SHEET NO. A2-03
Project No. : 21/16	



1 ELEVATION (7) / EXISTING
1:100




2 ELEVATION (7) / Interventions
1:100




2 ELEVATION (7) / Proposed
1:100



3 ELEVATION (8) / EXISTING
1:100

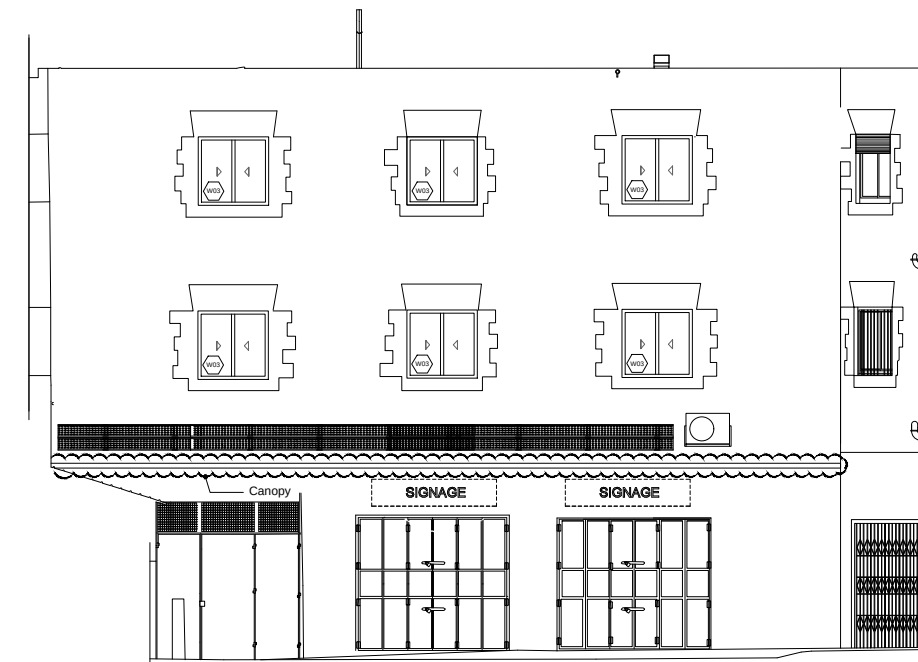


4 ELEVATION (8) / Interventions
1:100

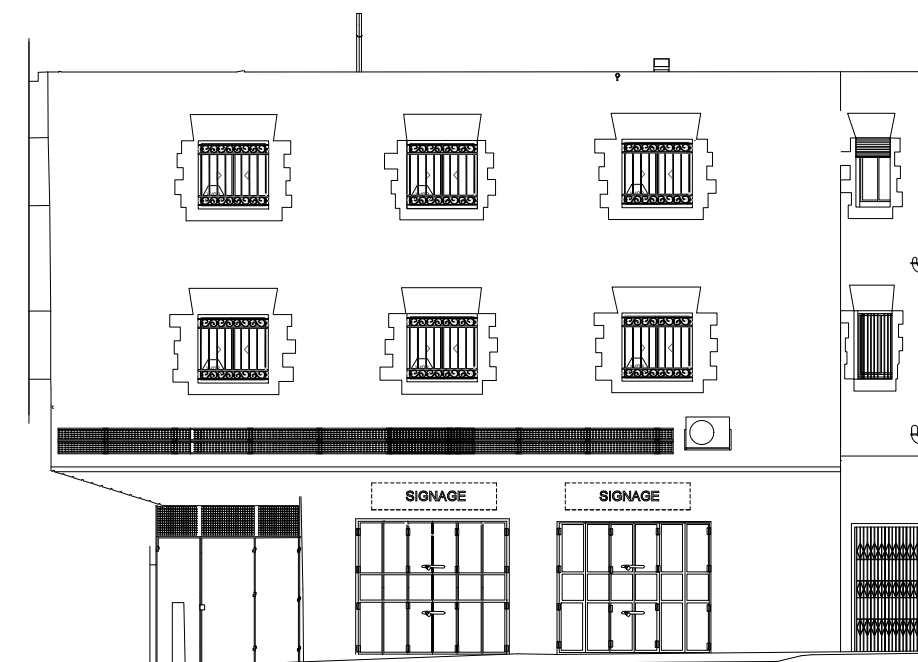

4 ELEVATION (8) / Proposed
1:100

دائرة الأوقاف الإسلامية في القدس

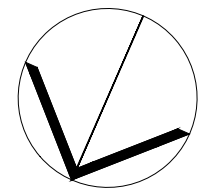

REV.	SUBJECT	DATE	BY
03			
02			
01			

NOTES:
- All Levels in meter
- All dimensions are shown in centimeters.

LEGEND:	
1- REINFORCED CONCRETE	
2- CONCRETE	
3- STONE	
4- CONCRETE BLOCK	
5- YTONG BLOCK	
5- BASE COURSE	
6- SAND	
7- COMPACTED FILL OR NATURAL GROUND	
8- LEVEL SYMBOL (PLAN)	±0.00 F.F.L. -0.12 C.F.L.
10- LEVEL SYMBOL (SECTION - ELEVATION)	±0.00 F.F.L. C.F.L.
11- FINISH FLOOR LEVEL	F.F.L.
12- CONCRETE FLOOR LEVEL	C.F.L.
13- WINDOW LABEL	WINDOW NUMBER W1
14- DOOR LABEL	DOOR NUMBER D1
15- DETAILS SIGN	ELEVATION # SECTION # SHEET #
16- STRUCTURAL SYMBOLS - COLUMNS	
1- EXISTING COLUMN	
2- RC COLUMN	
3- COLUMN CONCRETE JACKETING	
4- COLUMN STEEL JACKETING	
* REF TO STRUCTURE DRAWINGS TO GET FINAL DATA	

PROJECT TITLE
PRODUCTIVITY& URBAN RENEWAL
IN EAST JERUSALEM (PURE)
RENOVATION WORKS OF
BUILDING SS004

SHEET TITLE:
Elevations (7) & (8)

CONSULTANTS:
ZIADAH
ARCHITECTS & ENGINEERS
معماريون ومهندسون
DOUR
ENGINEERING & PLANNING
CONSULTING ENGINEERS

Scale : 1:100 When Printed At Sheet (A1)	Date : 16 September 2017
Design by : ZIADAH CONSULTANTS	Division : ARCHITECTURAL
checked by : ZIADAH CONSULTANTS	SHEET NO. A2-04
Drawn by : ZIADAH CONSULTANTS	
Project No. : 21/16	




1 ELEVATION (9) / EXISTING
1:100




2 ELEVATION (9) / Interventions
1:100



2 ELEVATION (9) / Proposed
1:100

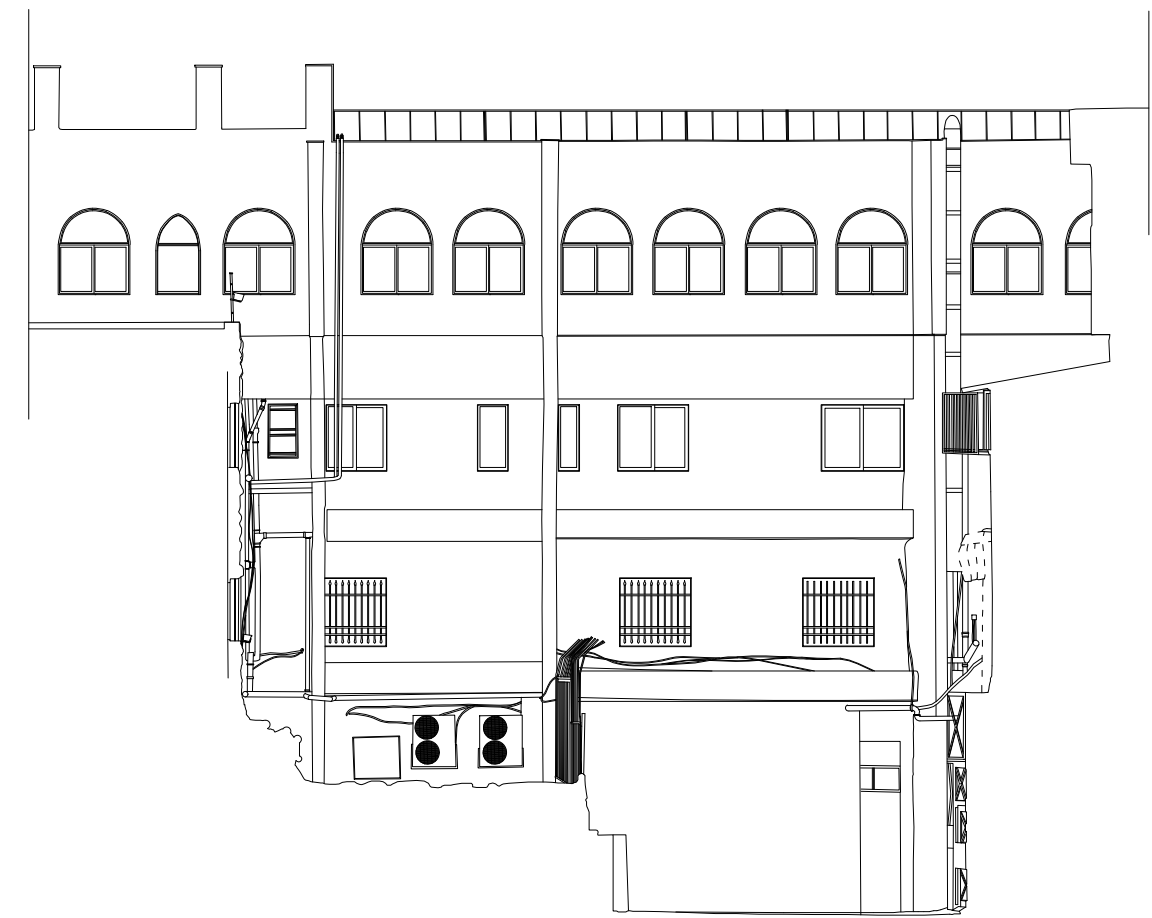

3 ELEVATION (10) / EXISTING
1:100

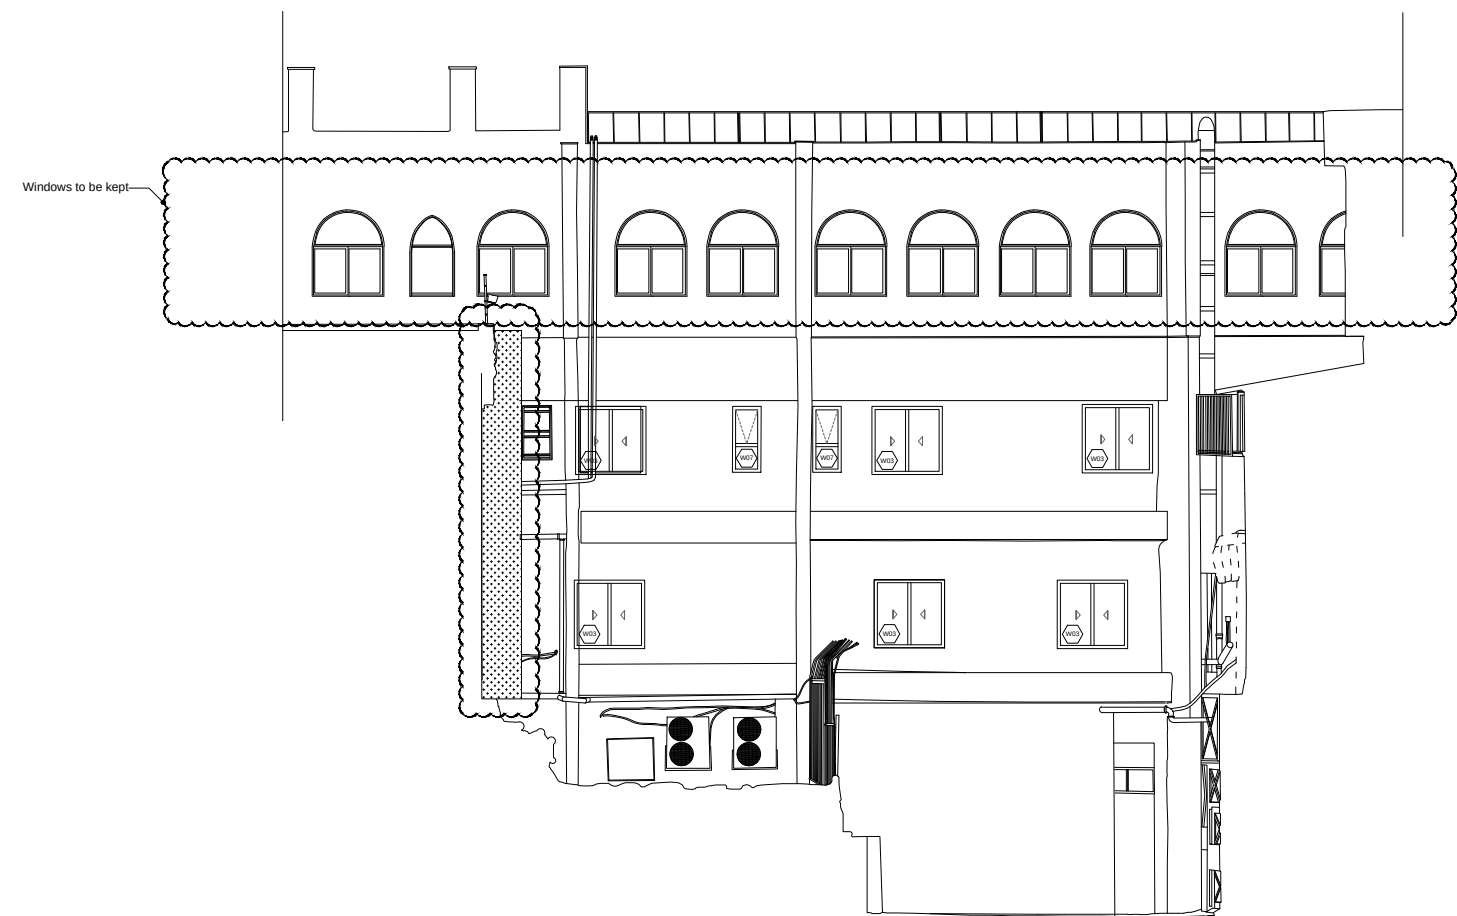


4 ELEVATION (10) / Interventions
1:100



4 ELEVATION (10) / Proposed
1:100

دائرة الأوقاف الإسلامية في القدس

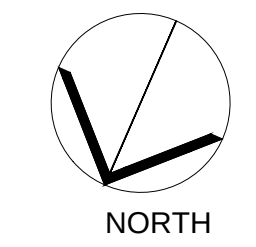

REV.	SUBJECT	DATE	BY
03			
02			
01			

NOTES:
- All Levels in meter
- All dimensions are shown in centimeters.


LEGEND:	
1- REINFORCED CONCRETE	
2- CONCRETE	
3- STONE	
4- CONCRETE BLOCK	
5- YTONG BLOCK	
5- BASE COURSE	
6- SAND	
7- COMPACTED FILL OR NATURAL GROUND	
8- LEVEL SYMBOL (PLAN)	
10- LEVEL SYMBOL (SECTION - ELEVATION)	
11- FINISH FLOOR LEVEL	
12- CONCRETE FLOOR LEVEL	
13- WINDOW LABEL	
14- DOOR LABEL	
15- DETAILS SIGN	
16- STRUCTURAL SYMBOLS - COLUMNS	
1- EXISTING COLUMN	
2- RC COLUMN	
3- COLUMN CONCRETE JACKETING	
4- COLUMN STEEL JACKETING	
* REF TO STRUCTURE DRAWINGS TO GET FINAL DATA	

PROJECT TITLE
PRODUCTIVITY& URBAN RENEWAL
IN EAST JERUSALEM (PURE)
RENOVATION WORKS OF
BUILDING SS004


SHEET TITLE:
Elevations (9) & (10)

CONSULTANTS:
ZIADAH
ARCHITECTS & ENGINEERS
معماريون ومهندسون
DOUR
ENGINEERING & PLANNING
CONSULTING ENGINEERS


Scale : 1:100 When Printed At Sheet (A1)	Date : 16 September 2017
Design by : ZIADAH CONSULTANTS	
checked by: ZIADAH CONSULTANTS	Division : ARCHITECTURAL
Drawn by: ZIADAH CONSULTANTS	SHEET NO. A2-05
Project No. 21/16	

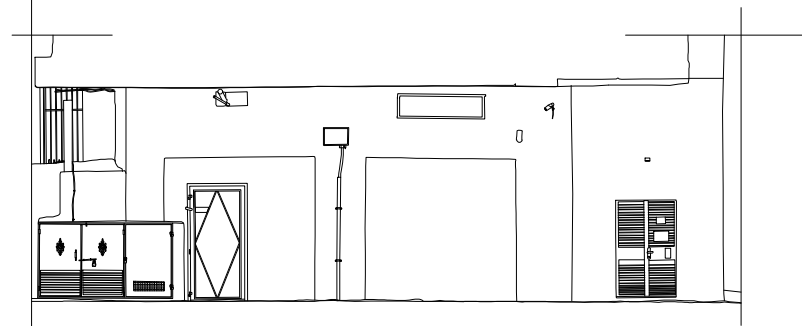


3 ELEVATION (12) / EXISTING
1:100

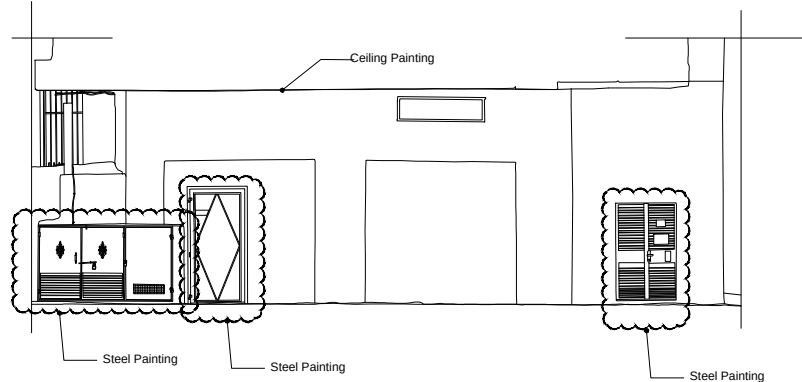


4 ELEVATION (12) / Interventions
1:100

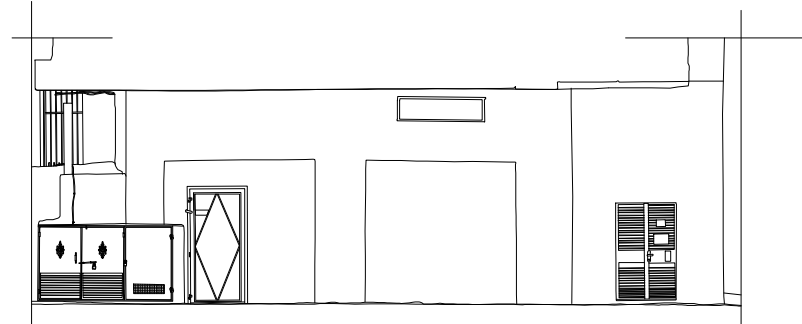

4 ELEVATION (12) / Proposed
1:100

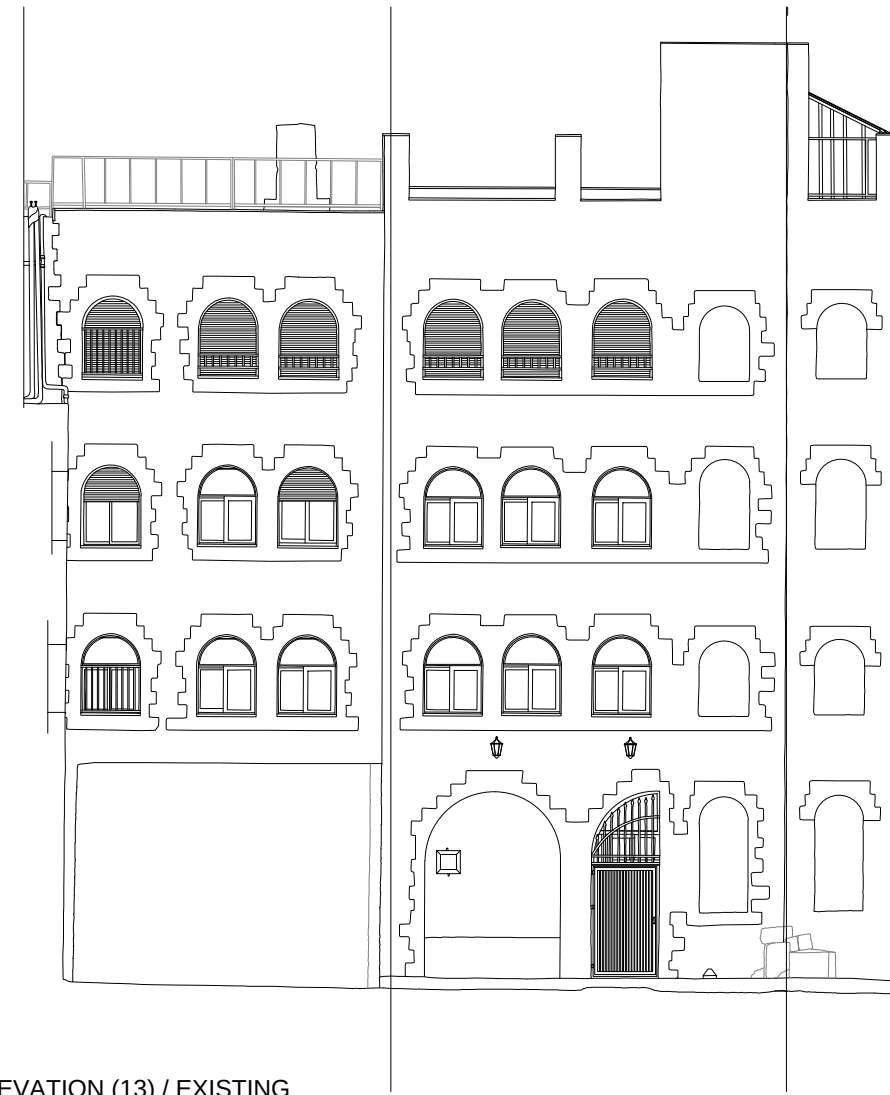

5 ELEVATION (13) / EXISTING
1:100

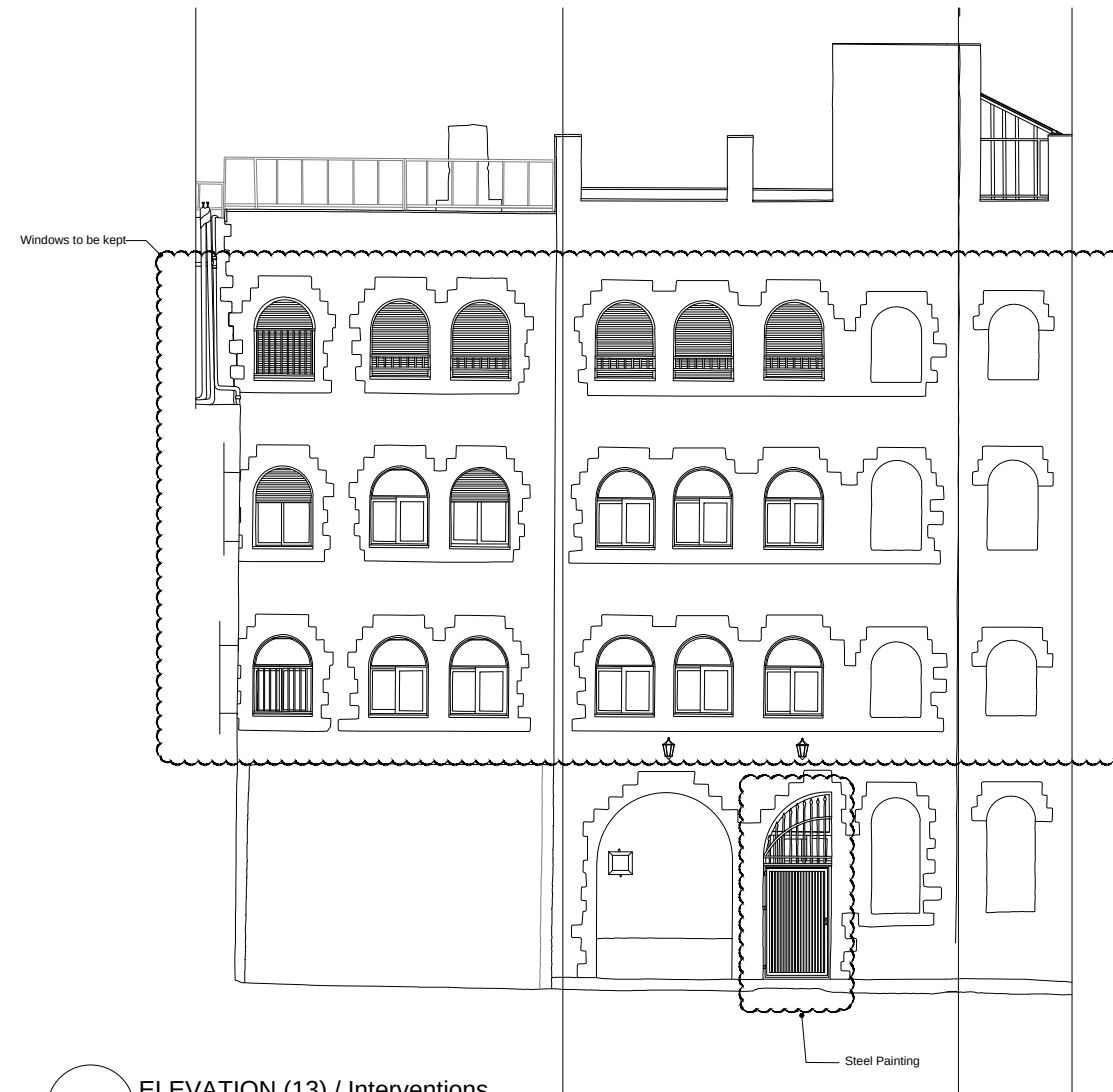


6 ELEVATION (13) / Interventions
1:100



6 ELEVATION (13) / Proposed
1:100

دائرة الأوقاف الإسلامية في القدس

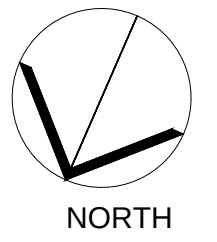

03			
02			
01			
REV.	SUBJECT	DATE	BY

NOTES:
- All Levels in meter
- All dimensions are shown in centimeters.

LEGEND:	
1- REINFORCED CONCRETE	
2- CONCRETE	
3- STONE	
4- CONCRETE BLOCK	
5- YTONG BLOCK	
5- BASE COURSE	
6- SAND	
7- COMPACTED FILL OR NATURAL GROUND	
8- LEVEL SYMBOL (PLAN)	
10- LEVEL SYMBOL (SECTION - ELEVATION)	
11- FINISH FLOOR LEVEL	
12- CONCRETE FLOOR LEVEL	
13- WINDOW LABEL	
14- DOOR LABEL	
15- DETAILS SIGN	
16- STRUCTURAL SYMBOLS - COLUMNS	
1- EXISTING COLUMN	
2- RC COLUMN	
3- COLUMN CONCRETE JACKETING	
4- COLUMN STEEL JACKETING	
* REF TO STRUCTURE DRAWINGS TO GET FINAL DATA	


PROJECT TITLE
PRODUCTIVITY& URBAN RENEWAL
IN EAST JERUSALEM (PURE)

RENOVATION WORKS OF
BUILDING SS004

SHEET TITLE:
Elevations (11), (12) & (13)

CONSULTANTS:
ZIADAH
ARCHITECTS & ENGINEERS
معماريون ومهندسون
DOUR
ENGINEERING & PLANNING
CONSULTING ENGINEERS

Scale : 1:100 When Printed At Sheet (A1)	Date : 16 September 2017
Design by : ZIADAH CONSULTANTS	
checked by : ZIADAH CONSULTANTS	Division : ARCHITECTURAL
Drawn by : ZIADAH CONSULTANTS	SHEET NO. A2-06
Project No. 21/16	

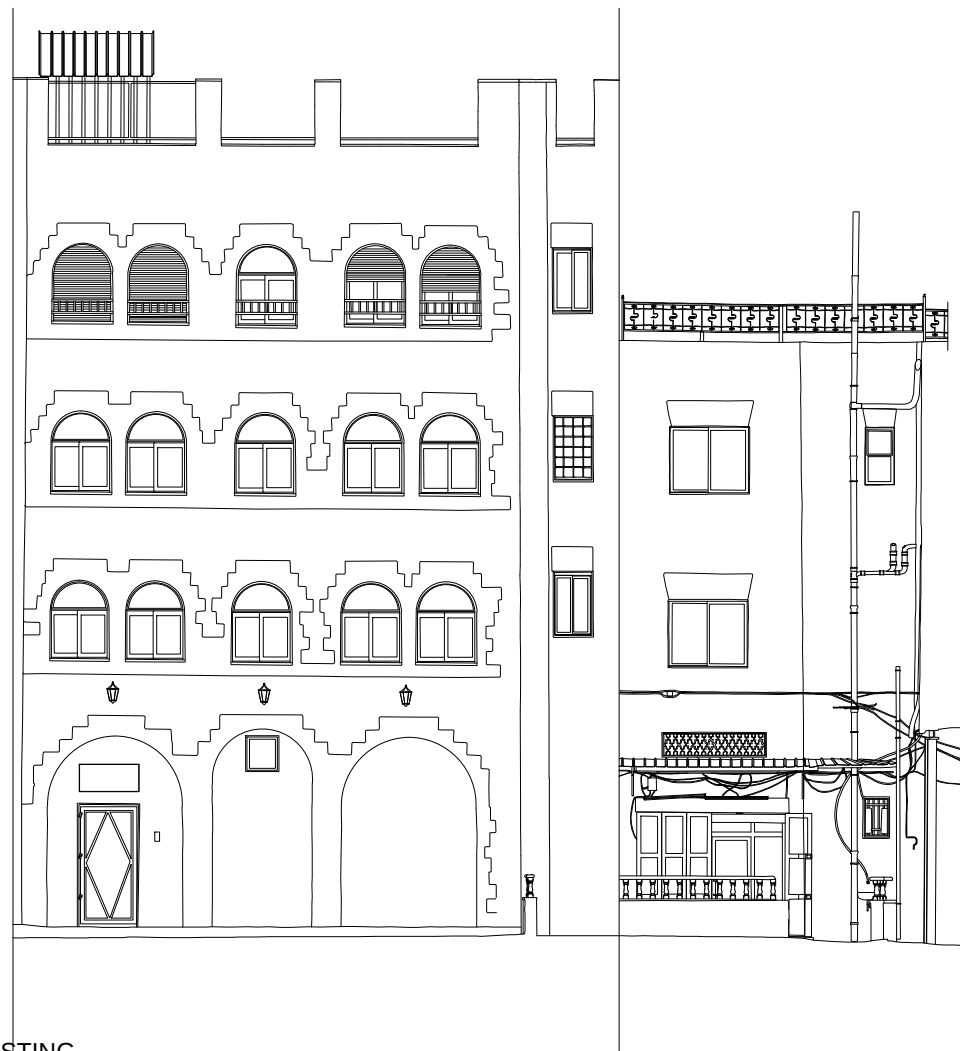


1 ELEVATION (14) / EXISTING
1:100




2 ELEVATION (14) / Interventions
1:100




2 ELEVATION (14) / Proposed
1:100

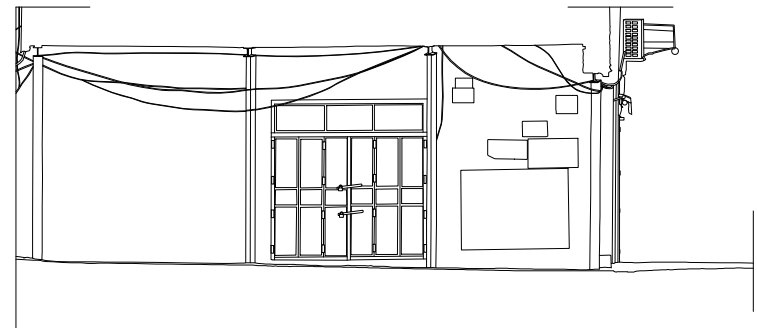

3 ELEVATION (15) / EXISTING
1:100

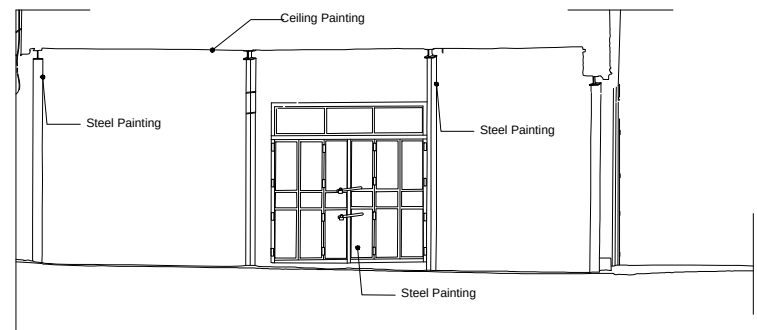


4 ELEVATION (15) / Interventions
1:100

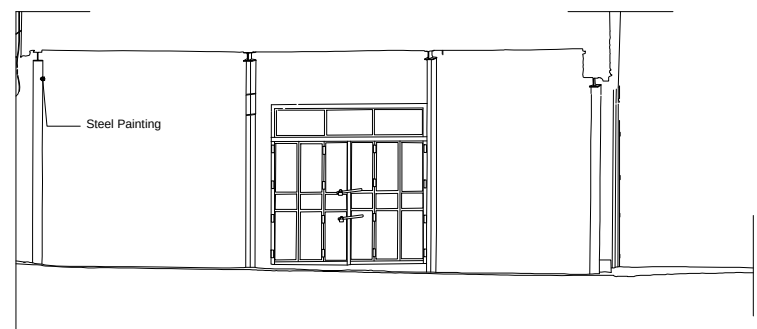

4 ELEVATION (15) / Proposed
1:100

دائرة الأوقاف الإسلامية في القدس

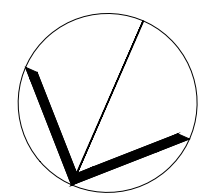

NORTH

03			
02			
01			
REV.	SUBJECT	DATE	BY

NOTES:
- All Levels in meter
- All dimensions are shown in centimeters.
.....
.....

LEGEND:	
1- REINFORCED CONCRETE	
2- CONCRETE	
3- STONE	
4- CONCRETE BLOCK	
5- YTONG BLOCK	
5- BASE COURSE	
6- SAND	
7- COMPACTED FILL OR NATURAL GROUND	
8- LEVEL SYMBOL (PLAN)	
10- LEVEL SYMBOL (SECTION - ELEVATION)	
11- FINISH FLOOR LEVEL	
12- CONCRETE FLOOR LEVEL	
13- WINDOW LABEL	
14- DOOR LABEL	
15- DETAILS SIGN	
16- STRUCTURAL SYMBOLS - COLUMNS	
1- EXISTING COLUMN	
2- RC COLUMN	
3- COLUMN CONCRETE JACKETING	
4- COLUMN STEEL JACKETING	
* REF TO STRUCTURE DRAWINGS TO GET FINAL DATA	

PROJECT TITLE
PRODUCTIVITY& URBAN RENEWAL
IN EAST JERUSALEM (PURE)
RENOVATION WORKS OF
BUILDING SS004

SHEET TITLE:
Elevations (14) & (15)

CONSULTANTS:
ZIADAH
ARCHITECTS & ENGINEERS
معماريون ومهندسون
DOUR
ENGINEERING & PLANNING
CONSULTING ENGINEERS

Scale : 1:100 When Printed At Sheet (A1)	Date : 16 September 2017
Design by : ZIADAH CONSULTANTS	
checked by: ZIADAH CONSULTANTS	Division : ARCHITECTURAL
Drawn by: ZIADAH CONSULTANTS	SHEET NO. A2-07
Project No. 21/16	

دائرة الأوقاف الإسلامية في القدس



03			
02			
01			
REV.	SUBJECT	DATE	BY

NOTES:
- All Levels in meter
- All dimensions are shown in centimeters.

1- REINFORCED CONCRETE	
2- CONCRETE	
3- STONE	
4- CONCRETE BLOCK	
5- YTONG BLOCK	
5- BASE COURSE	
6- SAND	
7- COMPACTED FILL OR NATURAL GROUND	
8- LEVEL SYMBOL (PLAN)	±0.00 F.F.L
10- LEVEL SYMBOL (SECTION – ELEVATION)	-0.12 C.F.L
11- FINISH FLOOR LEVEL	F.F.L
12- CONCRETE FLOOR LEVEL	C.F.L
13- WINDOW LABEL	WINDOW NUMBER
14- DOOR LABEL	DOOR NUMBER
15- DETAILS SIGN	ELEVATION / SECTION / SHEET
16- STRUCTURAL SYMBOLS – COLUMNS	
1- EXISTING COLUMN	
2- RC COLUMN	
3- COLUMN CONCRETE JACKETING	
4- COLUMN STEEL JACKETING	
* REF TO STRUCTURE DRAWINGS TO GET FINAL DATA	

PROJECT TITLE
PRODUCTIVITY& URBAN RENEWAL
IN EAST JERUSALEM (PURE)

RENOVATION WORKS OF
BUILDING SS004


SHEET TITLE:

Doors & Windows


CONSULTANTS:
ZIADAH
ARCHITECTS & ENGINEERS
معماريون ومهندسون
DOUR
ENGINEERING & PLANNING
CONSULTING ENGINEERS

Scale : 1:100 When Printed At Sheet (A1)	Date : 16 September 2017
Design by : ZIADAH CONSULTANTS	
checked by: ZIADAH CONSULTANTS	Division : ARCHITECTURAL
Drawn by: ZIADAH CONSULTANTS	SHEET NO. A6-01
Project No. 21/16	

All Doors Schedule				
WINDOW TYPE	Count (No.)	Width (cm)	Height (cm)	Window Material
D01	11	180	210	Impermeable door
D02	1	180	240	Double leaf Impermeable glass door
All dimensions are approximate. Exact dimensions shall be taken on site				

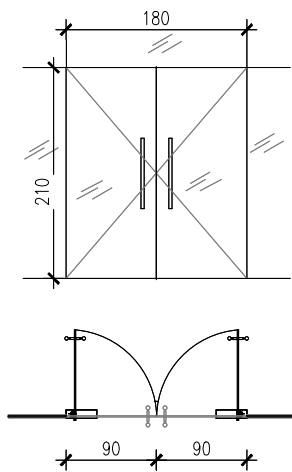


1 D01
1:50

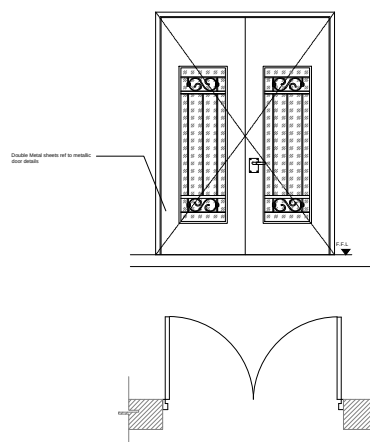


1 D08
1:50


All Windows Schedule				
WINDOW TYPE	Count (No.)	Width (cm)	Height (cm)	Window Material
W01	5	154	104	Aluminum
W02	5	110	110	Aluminum
W03	3	136	136	Aluminum
W04	40	136	27	Aluminum
W05	9	110	140	Aluminum
W06	1	136	136	Aluminum
W07	3	136	54	Aluminum
W08	4	140	24	Aluminum
W09	1	140	140	Aluminum
W10	1	140	140	Aluminum
W11	1	140	140	Aluminum
All dimensions are approximate. Exact dimensions shall be taken on site				

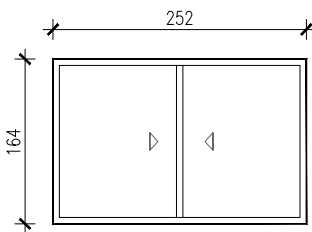


1 W01
1:50

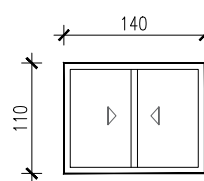


1 W05
1:50

 


1 W09
1:50

 


1 W02
1:50

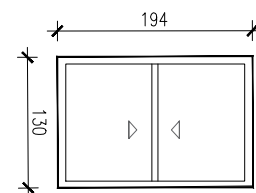


1 W06
1:50

 


1 W10
1:50

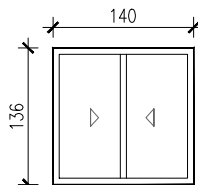


1 W03
1:50

 


1 W07
1:50

 

1 W11
1:50

 

1 W04
1:50

 

1 W08
1:50

OWNER:

دائرة الاوقاف الإسلامية في القدس




PROJECT TITLE:

**PRODUCTIVITY AND URBAN RENEWAL IN EAST JERUSALEM
(PURE)**

Renovation Works of Buildings SS004

Mechanical Drawings

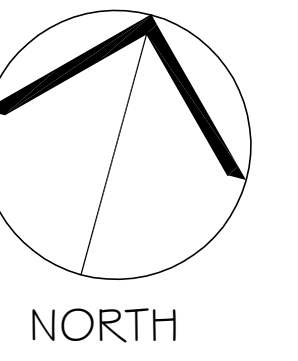

03			
02			
01			
REV.	SUBJECT	DATE	BY

NOTES:

- All Levels in meter
- All dimensions are shown in centimeters

.....

.....

LEGEND:

PROJECT TITLE


PRODUCTIVITY & URBAN RENEWAL
IN EAST JERUSALEM (PURE)

RENOVATION WORKS OF
BUILDING S5004


SHEET TITLE:

LIST OF DRAWINGS

CONSULTANTS:

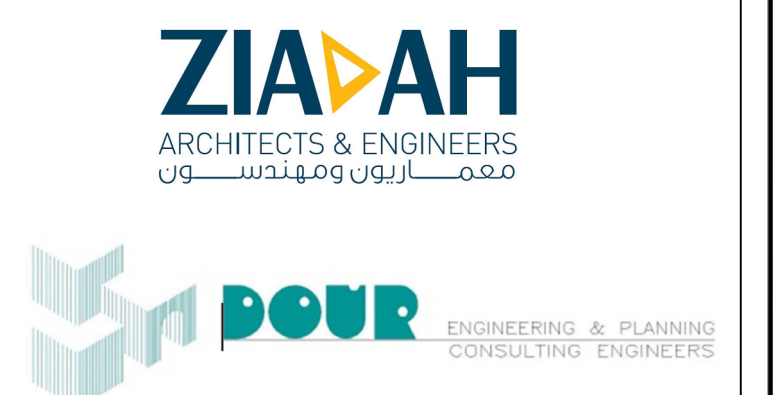

Scale : 1:100 When Printed At Sheet (A0)	Date : 16/09/2017
Design by : ZIADAH CONSULTANTS	
checked by: ZIADAH CONSULTANTS	Division : MECHANICAL
Drawn by: ZIADAH CONSULTANTS	SHEET NO. M0-00
Project No. 21/16	

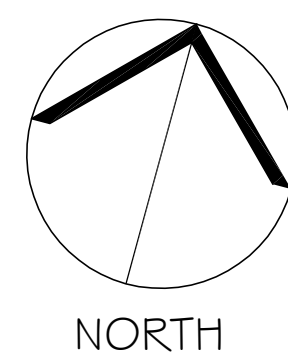

03			
02			
01			
REV.	SUBJECT	DATE	BY


NOTES:
- All Levels in meter
- All dimensions are shown in centimeters

LEGEND:

PROJECT TITLE
PRODUCTIVITY4 URBAN RENEWAL
IN EAST JERUSALEM (PURE)

RENOVATION WORKS OF
BUILDING S5004

SHEET TITLE:
LIST OF SYMBOLS

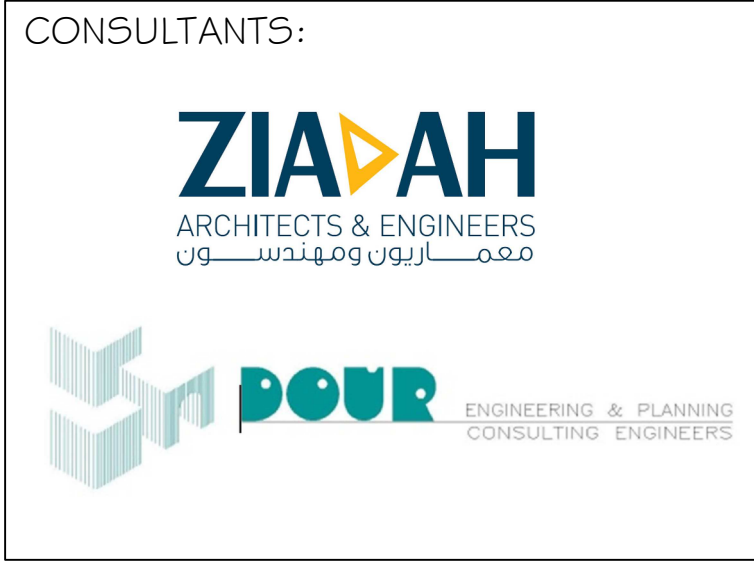

Scale : 1 : 100 When Printed At: Sheet (A0)	Date : 16/09/2017
Design by : ZIADAH CONSULTANTS	
checked by: ZIADAH CONSULTANTS	Division : MECHANICAL
Drawn by: ZIADAH CONSULTANTS	SHEET NO. M0-0
Project No. : 21/16	

VENTILATION,AC

SYMPOL	DESCRIPTION
	INDOOR SPLIT UNIT
	IN LINE FAN
	CIRCULAR GRILLE
	INDOOR CASSETTE UNIT
	OUT DOOR UNIT
	COPPER REFRIGERANT PIPE
	4 WAY SUPPLY DIFFUSER

APPREVIATIONS

SYMPOL	DESCRIPTION
CO	CLEAN OUT
F/A	FROM ABOVE
T/A	TO ABOVE
F/B	FROM BELOW
T/B	TO BELOW
OD	OUT DOOR UNIT
ID	IN DOOR UNIT
VD	VOLUME DAMPER
FD	FIRE DAMPER
B,S,P	BLACK STEEL PIPE
PPR	POLYPROPYLENE
PRV	PRESSURE REGULATING VALVE
NRV	NON-RETURN VALVE
IV	ISOLATING VALVE

GAS

SYMPOL	DESCRIPTION
	GAS RISER
	GAS PIPE

FIRE FIGHTING


SYMPOL	DESCRIPTION
	FIRE CABINET
	FIRE RISER
	BLACK STEEL PIPE
	FIRE HYDRANT CABINET
	POWER FIRE EXTINGUISHER

SANITARY

SYMPOL	DESCRIPTION
	FLOOR TRAP
	SEWAR RISER
	CLEAN OUT
	DRAIN MANHOLE
	CEILING CLEAN OUT
	4" HDPE PIPE
	2" HDPE PIPE
	FLOOR CLEANOUT

WATER

	COLD WATER RISER
	WATER MANIFOLD
	HOT WATER XLPE
	COLD WATER XLPE
	COLD WATER PPR PIPE
	HOT WATER GALVANIZED PIPE

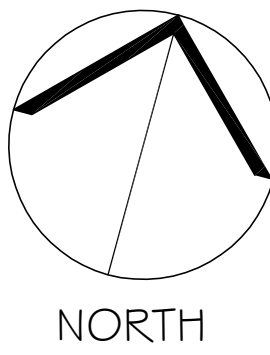

03			
02			
01			
REV.	SUBJECT	DATE	BY

NOTES:

- All Levels in meter
- All dimensions are shown in centimeters

LEGEND:


PROJECT TITLE

PRODUCTIVITY4 URBAN RENEWAL
IN EAST JERUSALEM (PURE)

RENOVATION WORKS OF
BUILDING S5004

SHEET TITLE:

**DRAINAGE SYSTEM
-COURT AREA**

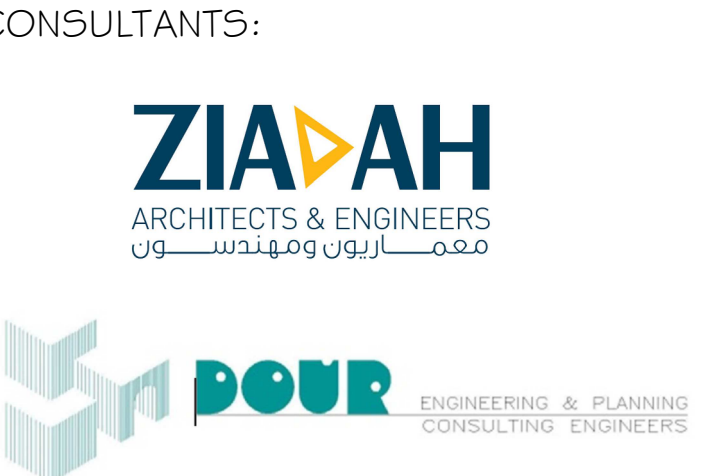

Scale :	Date :
1 : 100 When Printed At Sheet (A0)	16/09/2017
Design by :	
ZIADAH CONSULTANTS	
checked by :	Division :
ZIADAH CONSULTANTS	MECHANICAL
Drawn by :	SHEET NO.
ZIADAH CONSULTANTS	
Project No. 21/16	M0-1



03			
02			
01			
REV.	SUBJECT	DATE	BY

NOTES:

- All Levels in meter
- All dimensions are shown in centimeters

LEGEND:

PROJECT TITLE

PRODUCTIVITY4 URBAN RENEWAL
IN EAST JERUSALEM (PURE)

RENOVATION WORKS OF
BUILDING SS004

SHEET TITLE:


ROOF DRAIN LAYOUT

CONSULTANTS:

ZIADAH
ARCHITECTS & ENGINEERS
مهندسون معماريون ومهندسون

POUR
ENGINEERING & PLANNING
CONSULTING ENGINEERS

Scale : 1 : 100 When Printed At Sheet (A0)	Date : 16/09/2017
Design by : ZIADAH CONSULTANTS	Division : MECHANICAL
checked by:	
Drawn by: ZIADAH CONSULTANTS	SHEET NO. M0-2
Project No. : 21/16	

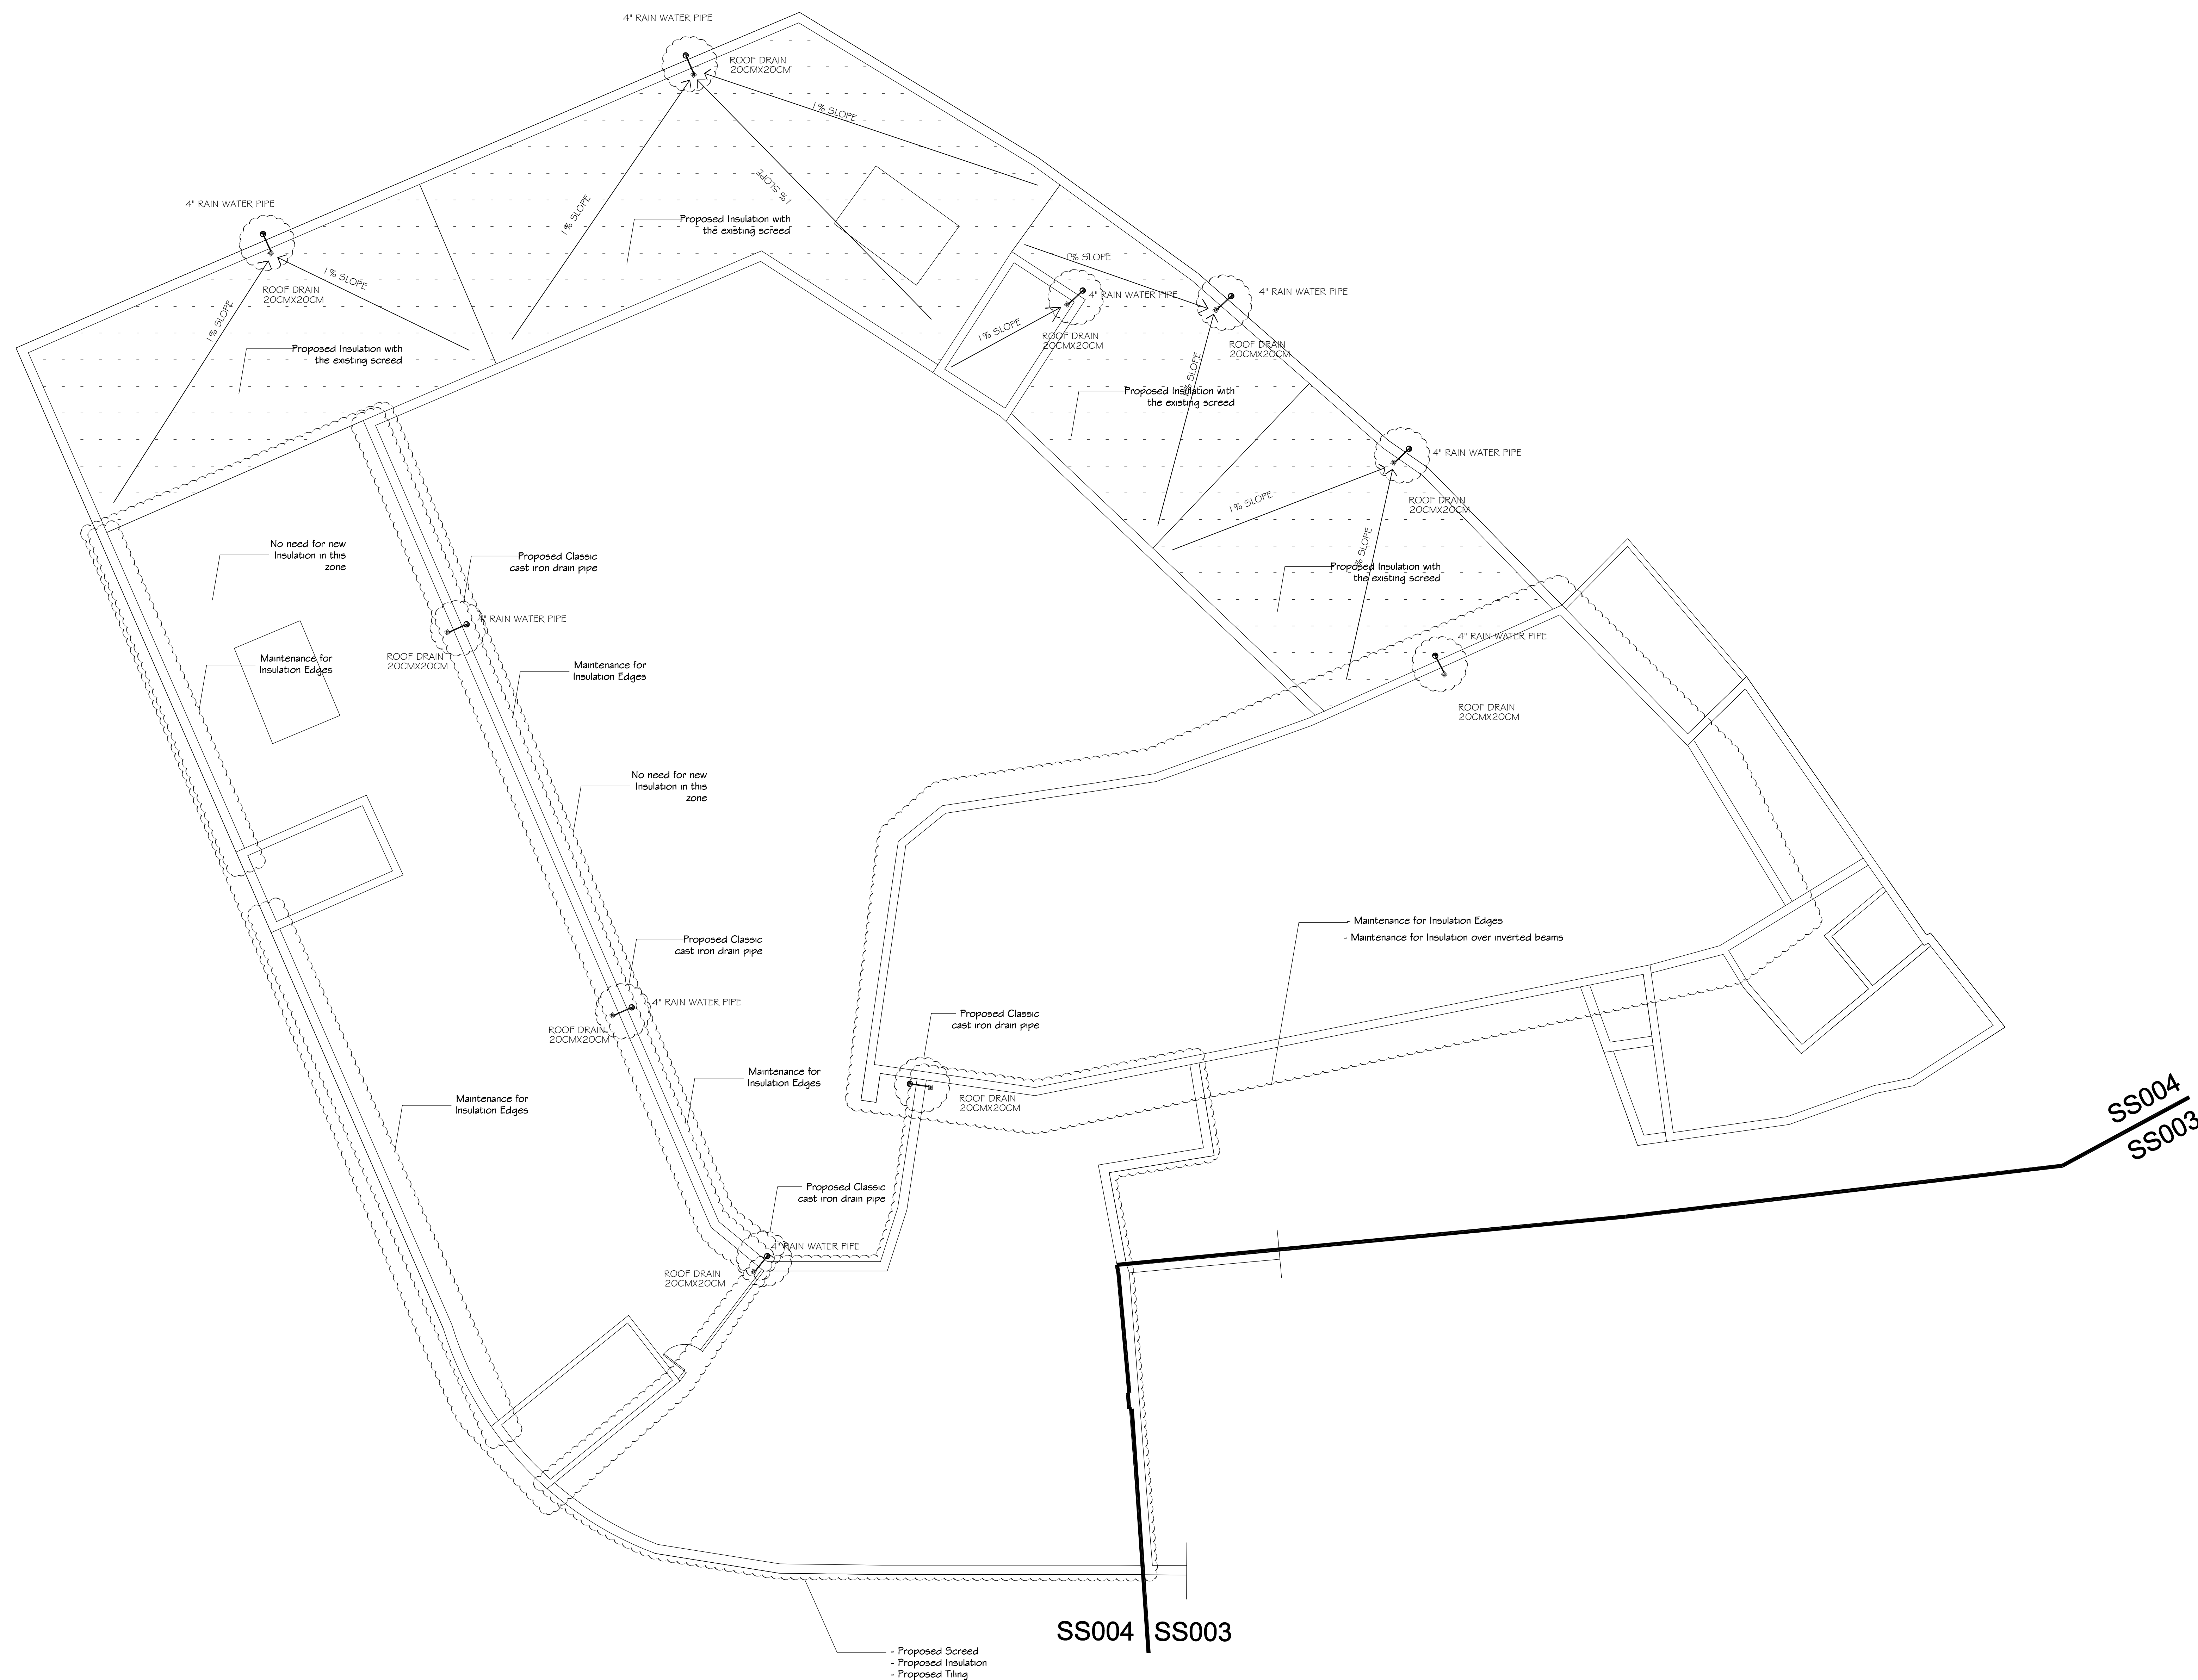



03			
02			
01			
REV.	SUBJECT	DATE	BY

NOTES:

- All Levels in meter
- All dimensions are shown in centimeters

LEGEND:

PROJECT TITLE

PRODUCTIVITY4 URBAN RENEWAL
IN EAST JERUSALEM (PURE)

RENOVATION WORKS OF
BUILDING SS004

SHEET TITLE:

**HVAC LAYOUT
-GROUND FLOOR**


CONSULTANTS:

ZIADAH
ARCHITECTS & ENGINEERS
مهندسون معماريون ومهندسون


POUR
ENGINEERING & PLANNING
CONSULTING ENGINEERS

Scale : 1 : 100 When Printed At Sheet (A0)	Date : 16/09/2017
Design by : ZIADAH CONSULTANTS	Division : MECHANICAL
checked by : ZIADAH CONSULTANTS	SHEET NO. M0-3
Drawn by : ZIADAH CONSULTANTS	
Project No. : 21/16	



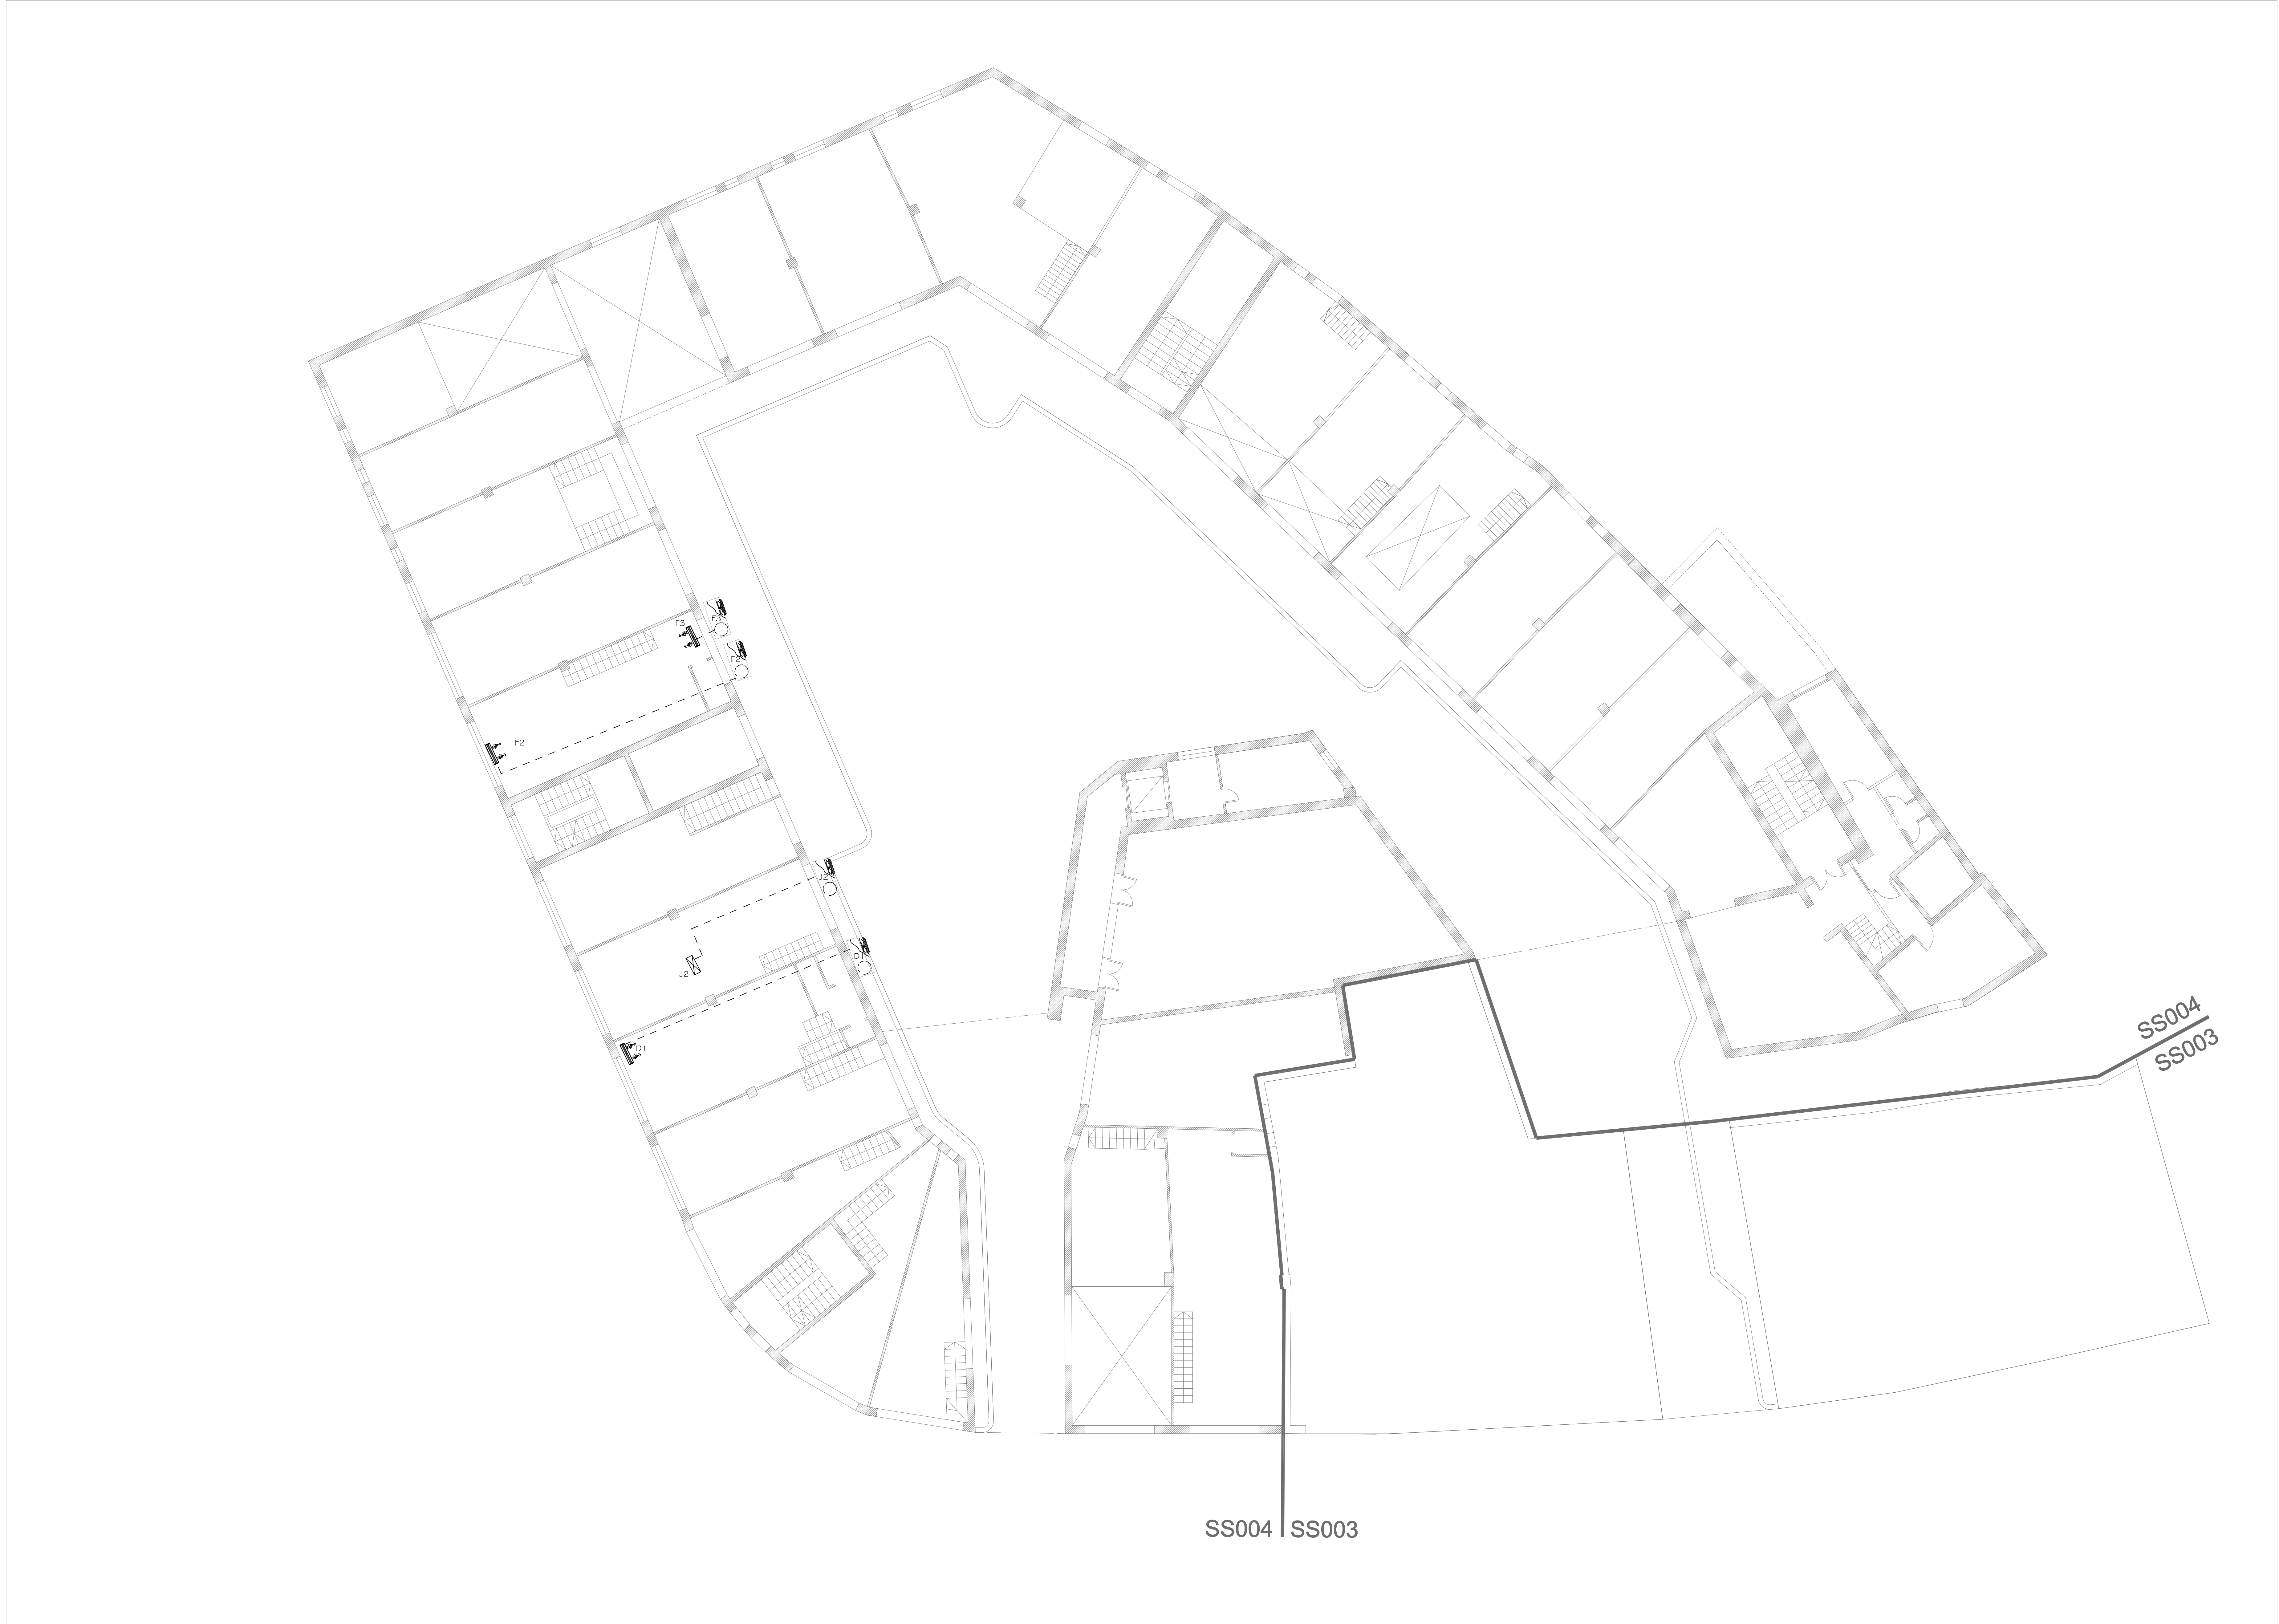

دائرة الأوقاف الإسلامية في القدس

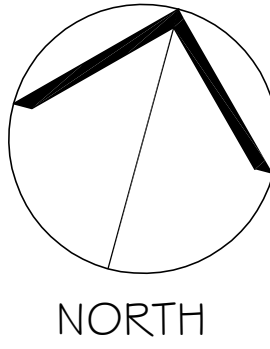

03			
02			
01			
REV.	SUBJECT	DATE	BY

NOTES:
- All Levels in meter
- All dimensions are shown in centimeters

LEGEND:

PROJECT TITLE
PRODUCTIVITY4 URBAN RENEWAL
IN EAST JERUSALEM (PURE)
RENOVATION WORKS OF
BUILDING SS004

SHEET TITLE:
HVAC LAYOUT
-MEZZ FLOOR

CONSULTANTS:
ZIADAH
ARCHITECTS & ENGINEERS
مهندسون معماريون ومهندسون
POUR
ENGINEERING & PLANNING
CONSULTING ENGINEERS

Scale : 1 : 100 When Printed At Sheet (A0)	Date : 16/09/2017
Design by : ZIADAH CONSULTANTS	Division : MECHANICAL
checked by : ZIADAH CONSULTANTS	SHEET NO. M0-4
Drawn by : ZIADAH CONSULTANTS	Project No. : 21/16

ELECTRICAL DRAWINGS TABLE	
Sheet Number	Sheet Name
E00	LIST OF DRAWINGS
E01	LEGEND
E101	GROUND LEVEL-POWER POINTS PLAN
E102	MEZZANINE LEVEL-POWER POINTS PLAN
E201	GROUND LEVEL-F.A. POINTS PLAN
E202	MEZZANINE LEVEL-F.A. POINTS PLAN
E301	GROUND LEVEL- L.V. POINTS PLAN
E302	MEZZANINE LEVEL- L.V. POINTS PLAN
E303	ROOF LEVEL- L.V. POINTS PLAN
E401	COURT PLAN -LIGHT POINTS PLAN
E501	SCHEMATIC-1
E601	ELECTRICAL DETAILS


دائرة الأوقاف الإسلامية في القدس



UNDP
United Nations Development Programme



EUROPEAN UNION

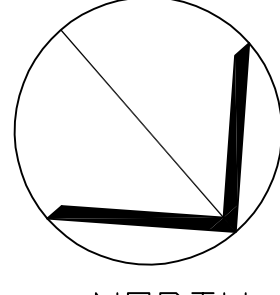

NORTH

03			
02			
01			
REV.	SUBJECT	DATE	BY

NOTES:

LEGEND:

PROJECT TITLE
PRODUCTIVITY& URBAN RENEWAL
IN EAST JERUSALEM (PURE)

RENOVATION WORKS OF
BUILDING SS004

SHEET TITLE:

Electrical Index

 
CONSULTANTS:



ARCHITECTS & ENGINEERS
مهندسين معماريين ومهندسين




ENGINEERING & PLANNING
CONSULTING ENGINEERS


Scale : 1:100 When Printed A1 Sheet (A0)	Date : 01/11/2017
Design by : ZIADAH CONSULTANTS	 0 5 10 meters
checked by: ZIADAH CONSULTANTS	Division : ELECTRICAL
Drawn by: ZIADAH CONSULTANTS	SHEET NO. E0-00
Project No:1/16	

LEGEND

SYMBOL	DESCRIPTION	SYMBOL	DESCRIPTION
	PUSH BUTTON SHUTTER SWITCH		6" INDOOR SIREN WITH FLASHER
	SINGLE GANGE SWITCHES/ NORMAL & WP		HEAT DETECTOR
	DOUBLE GANGES SWITCHES/ NORMAL & WP		PHOTO SMOKE DETECTOR
	TWO WAY SWITCH		CONTROL MODULE analogue addressable dual monitor module
	SINGLE POLE WITH LAMP FOR EXT.LIGHTING INTERMEDIATE SWITCH		BREAK GLASS
	HAND DRYER AC UNIT		FM 200
	SINGLE SOCKETS/ NORMAL AND WP		SMOKE DETECTOR ABOVE CEILING WITH INDICATOR
	DOUBLE SOCKETS/ NORMAL AND WP		FACP
	2-POLE ISOLATOR		EXTERNAL SIREN GAS DETECTOR
	4-POLE ISOLATOR		CLEAN AGENT ABORT BUTTON
	ELECTRICAL MOTOR		CLEAN AGENT RELEASE BUTTON
			FM200 - Clean Agent Fire Extinguishing System
	2-POLE SWITCH WITH LAMP FOR EXTERNAL SOCKETS		EARTH PIT
	VOLUME CONTROL		EARTH BUSBAR
	HORN STROBE		CHECK BOX
	CEILING MOUNTED SPEAKER		MAIN PEC
	END OF LINE		TELEPHONE HAND-HOLE
	MIC		ELECTRICAL HAND-HOLE
	DATA SOCKET		
	T.V SOCKET		KEYPAD
	TEL SOCKET		MAGNETIC LOCK
	POE POE DOME CAMERA		MOTION DETECTOR
	INTERNAL WALL MOUNTED CAMERA		
	EXTERNAL WALL MOUNTED CAMERA		
	INTERCOM KEYPAD		

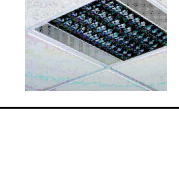PHOTO	SYMBOL	DESCRIPTION
	(A) 	A ceiling recessed LED downlight. Electronic, fixed output control gear. Body: Polycarbonate (PC), black. Reflector: satinbrite Polycarbonate (PC). Module support: white painted sheet steel. Heatsink: Aluminium, black. Class II electrical, IP20, IK03. Fixing clips suitable for ceiling thicknesses from 5-40 mm. Suitable for a variety of decorative attachments. No tools required. Cut-out Ø190 mm. Complete with 4000K LED fixed module. Dimensions: Ø205 x 150 mm, Total power: 15 W.
	(B) 	<i>DITTO, but with emergency kit / 3Hrs</i>
	(C) 	A round bulkhead LED luminaire. Electronic, fixed output control gear with 3 hour, manual test, emergency lighting circuit. Body: injection moulded Polycarbonate (PC). Bezel: injection moulded Polycarbonate (PC), white finish. Diffuser: opal Polycarbonate (PC). Electrical safety class I. Ingress protection IP54. Complete with 4000K LED. Dimensions: Ø327 x 105 mm, Total power: 13 W.
	(D) 	A value performance, low height, ceiling recessed LED downlight. Electronic, fixed output control gear. Body and reflector: Aluminium, powder coated white (RAL 9016). Diffuser: Polycarbonate (PC). Class II electrical, IP44, IK09. Spring clips suitable for ceiling thicknesses from 1 to 35mm. Cut-out Ø190mm. Complete with 4000K LED. Dimensions: Ø215 x 85 mm Total power: 12.8 W.
	(E) 	A self-contained, maintained emergency exit sign for 1 x 3W LED strip giving 3 hours manual test emergency operation. IP40, Class I electrical. Body in Polycarbonate (PC), finished white. Diffuser in Polycarbonate (PC). Can be wall mounted with 20mm conduit or rear back box entry. Legend panels required to be ordered separately in either ISO or EU formats. Complete with LED strip. Dimensions: 327 x 65 x 197 mm. Total power: 3 W.
	(F) 	IP65 dust and moisture resistant luminaire for 2 x 28W T16 lamp(s) with electronic - fixed output circuit. Class I electrical. Canopy: light grey polycarbonate, diffuser: polycarbonate with internal prisms, toggles: polycarbonate. For surface or suspended mounting.
	(G) 	<i>DITTO, but with emergency kit / 3Hrs</i>
	(H) 	Recessed modular luminaire for 4 x 14W T16 lamps with electronic fixed output control gear. Body in white painted steel with welded frame corners. Louvre in satinbrite aluminium with white painted infill panels. Dimensions: 597 x 597 x 59 mm
	(I) 	104watt outdoor floodlight Housing: In die-cast aluminium with cooling fins. Reflector: with symmetric and asymmetric beam options, made in polycarbonate with high-efficiency PVD metal surface finishing: the street lamp version is made in aluminium coated with very high purity (99.99%) silver using physical vapour deposition (PVD). Diffuser: 5mm thick tempered glass, resistant to thermal shocks and impacts. Coating: powder-coated with graphite grey polyester resin, resistant to corrosion and saline environments. Equipment: complete with mounting bracket and graduated scale goniometer which allows for accurate pointing; external connector for quick installation. Safety insulating switch to cut off power during maintenance. Silicone rubber gasket; external screws and bolts in stainless steel; air recirculation valve. Insulation piercing connector for quick installation with no need to open the fixture. Power factor: >= 0.9 Luminous flux maintenance 70% 50000h (L70820) LED 4000K - 14150lm - CRI 80 - 700mA - 104W - Low flicker - Surge protector 6/8kV LED 4000K - 21200lm - CRI 80 - 700mA - 156W - Low flicker - Surge protector 4/8kV Wind surface: L:390cm² F:1420cm² AS DISANO Rodio 1890 24LED or equivalent.

دائرة الأوقاف الإسلامية في القدس

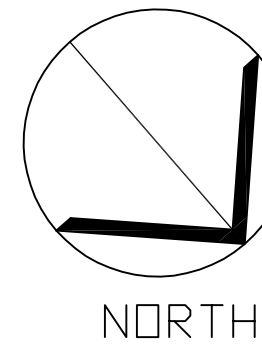

03			
02			
01			
REV.	SUBJECT	DATE	BY

NOTES:

LEGEND:

PROJECT TITLE


PRODUCTIVITY& URBAN RENEWAL
IN EAST JERUSALEM (PURE)

 
RENOVATION WORKS OF
BUILDING SS004


SHEET TITLE:

Electrical Legend

CONSULTANTS:

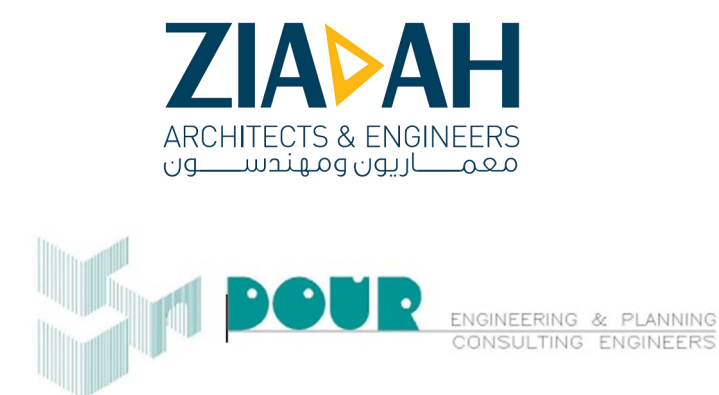

Scale : 1:100 When Printed A1 Sheet (A0)	Date : 01/11/2017
Design by : ZIADAH CONSULTANTS	
checked by: ZIADAH CONSULTANTS	Division : ELECTRICAL
Drawn by: ZIADAH CONSULTANTS	SHEET NO. E0-01
Project No:1/16	

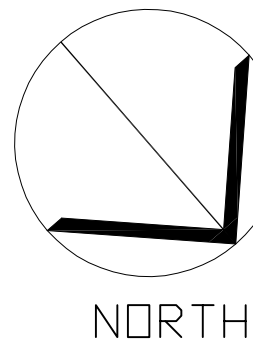

03				
02				
01				
REV.	SUBJECT	DATE	BY	

NOTES:

LEGEND:

PROJECT TITLE
PRODUCTIVITY & URBAN RENEWAL
IN EAST JERUSALEM (PURE)
RENOVATION WORKS OF
BUILDING SS004
SHEET TITLE:
Ground Floor
Power Points Plan


CONSULTANTS:
ZIAHAH
ARCHITECTS & ENGINEERS
مهندسين معماريين ومهندسين كهربائيين
DOUR
ENGINEERING & PLANNING
CONSULTING ENGINEERS

Scale : 1:100 When Printed A1 Sheet (A0)	Date : 01/11/2017
Design by : ZIAHAH CONSULTANTS	Division : ELECTRICAL
checked by: ZIAHAH CONSULTANTS	SHEET NO. E1-01
Drawn by: ZIAHAH CONSULTANTS	
Project No:1/16	





دائرة الأوقاف الإسلامية في القدس

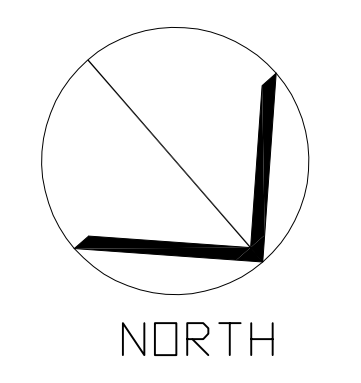

03			
02			
01			
REV.	SUBJECT	DATE	BY

NOTES:

LEGEND:

PROJECT TITLE
PRODUCTIVITY& URBAN RENEWAL
IN EAST JERUSALEM (PURE)
RENOVATION WORKS OF
BUILDING SS004


SHEET TITLE:
**Mezzanine Floor
Power Points Plan**

CONSULTANTS:


مهندسين معماريين ومهندسين مدنيين



Scale : 1:100 When Printed A1 Sheet (A0)	Date : 01/11/2017
Design by : ZIADAH CONSULTANTS	Division : ELECTRICAL
checked by: ZIADAH CONSULTANTS	SHEET NO. E1-02
Drawn by: ZIADAH CONSULTANTS	
Project No:1/16	

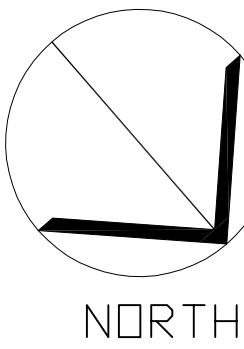

03			
02			
01			
REV.	SUBJECT	DATE	BY


NOTES:

LEGEND:

PROJECT TITLE
PRODUCTIVITY & URBAN RENEWAL
IN EAST JERUSALEM (PURE)
RENOVATION WORKS OF
BUILDING SS004

SHEET TITLE:
**Ground Floor
F.A. Points Plan**

CONSULTANTS:

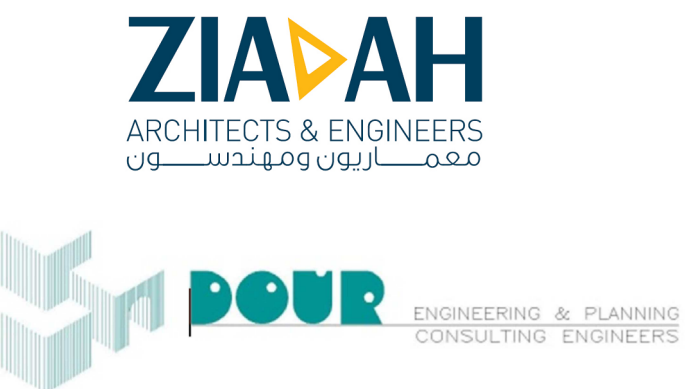


Scale : 1:100 When Printed A1 Sheet (A0)	Date : 01/11/2017
Design by : ZIAHAH CONSULTANTS	Division : ELECTRICAL
checked by: ZIAHAH CONSULTANTS	SHEET NO. E2-01
Drawn by: ZIAHAH CONSULTANTS	
Project No:1/16	





دائرة الأوقاف الإسلامية في القدس

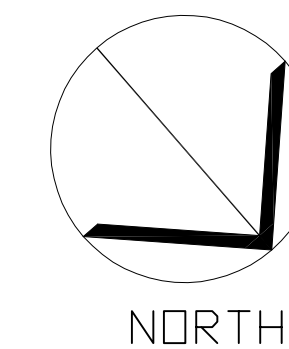


03			
02			
01			
REV.	SUBJECT	DATE	BY

NOTES:


LEGEND:

PROJECT TITLE
PRODUCTIVITY & URBAN RENEWAL
IN EAST JERUSALEM (PURE)
RENOVATION WORKS OF
BUILDING SS004

SHEET TITLE:
**Mezzanine Floor
F.A. Points Plan**

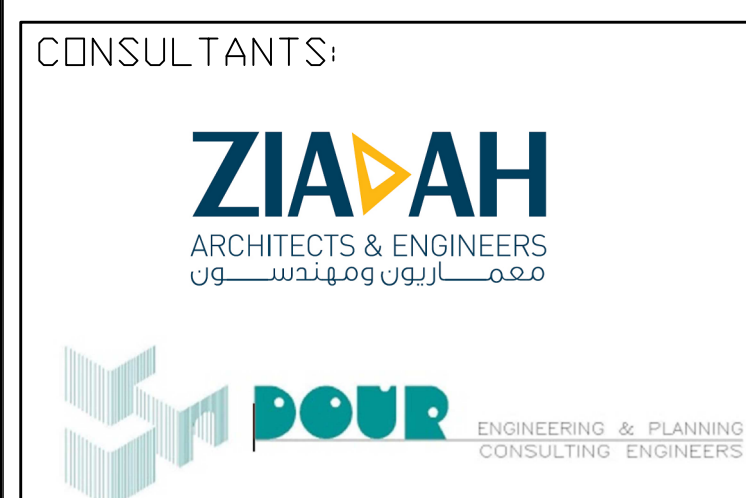

Scale : 1:100 When Printed A1 Sheet (A0)	Date : 01/11/2017
Design by : ZIADAH CONSULTANTS	Division : ELECTRICAL
checked by: ZIADAH CONSULTANTS	SHEET NO. E2-02
Drawn by: ZIADAH CONSULTANTS	
Project No:1/16	

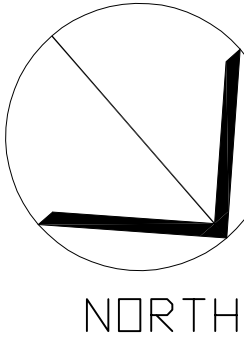

03			
02			
01			
REV.	SUBJECT	DATE	BY

NOTES:

LEGEND:


PROJECT TITLE
PRODUCTIVITY & URBAN RENEWAL
IN EAST JERUSALEM (PURE)
RENOVATION WORKS OF
BUILDING SS004

SHEET TITLE:
Ground Floor
L.V. Points Plan

CONSULTANTS:
ZIADAH
ARCHITECTS & ENGINEERS
مهندسون معماريون ومهندسون
DOUR
ENGINEERING & PLANNING
CONSULTING ENGINEERS

Scale : 1:100 When Printed A1 Sheet (A0)	Date : 01/11/2017
Design by : ZIADAH CONSULTANTS	Division : ELECTRICAL
checked by: ZIADAH CONSULTANTS	SHEET NO. E3-01
Drawn by: ZIADAH CONSULTANTS	
Project No:1/16	



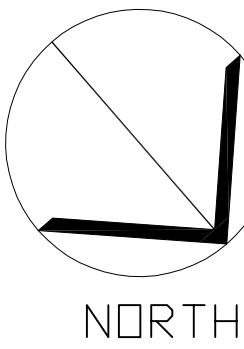

03			
02			
01			
REV.	SUBJECT	DATE	BY


NOTES:

LEGEND:

PROJECT TITLE
PRODUCTIVITY& URBAN RENEWAL
IN EAST JERUSALEM (PURE)
RENOVATION WORKS OF
BUILDING SS004


SHEET TITLE:
Mezzanine Floor
L.V. Points Plan

CONSULTANTS:

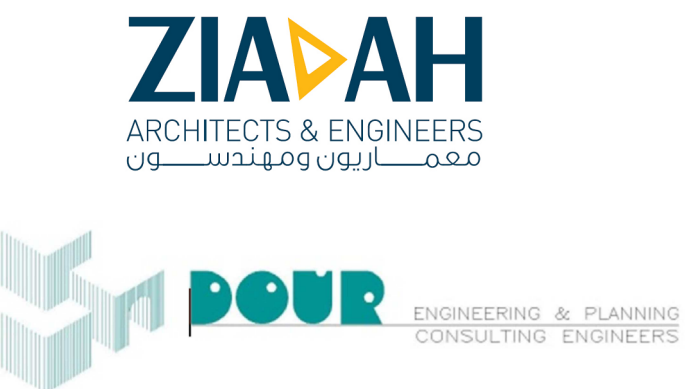


Scale : 1:100 When Printed A1 Sheet (A0)	Date : 01/11/2017
Design by : ZIADAH CONSULTANTS	Division : ELECTRICAL
checked by: ZIADAH CONSULTANTS	SHEET NO. E3-02
Drawn by: ZIADAH CONSULTANTS	
Project No:1/16	



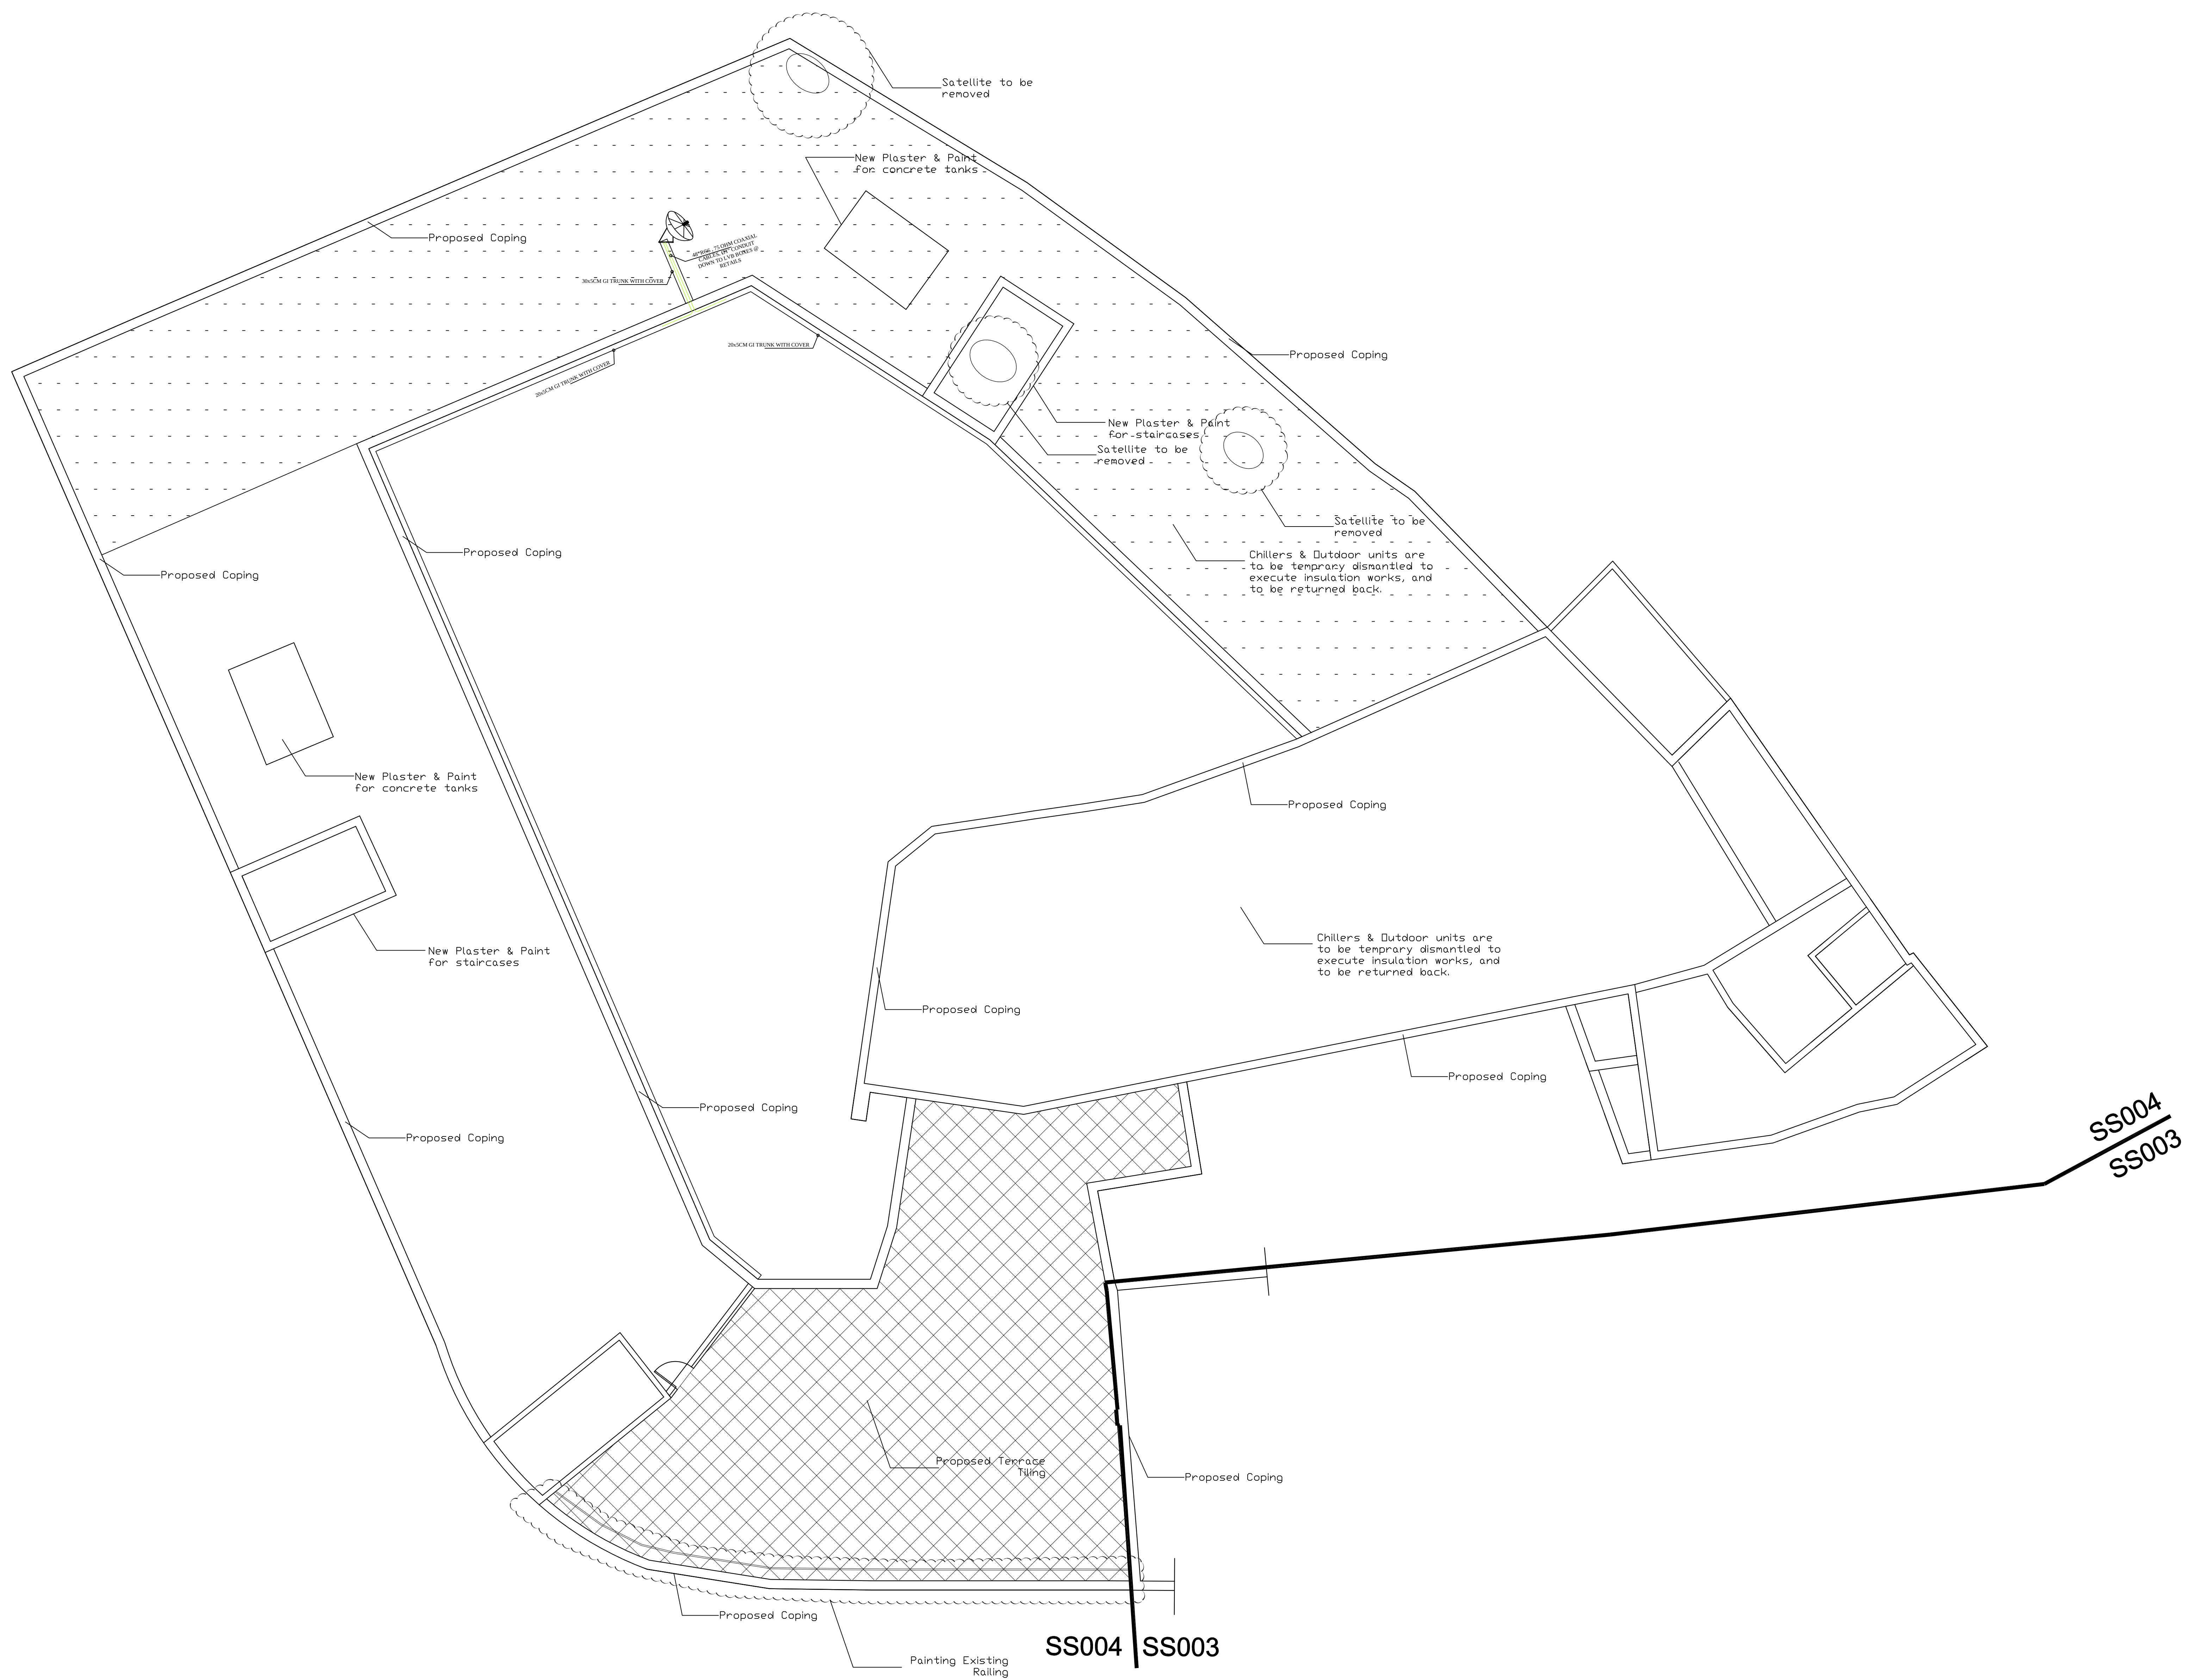

دائرة الأوقاف الإسلامية في القدس

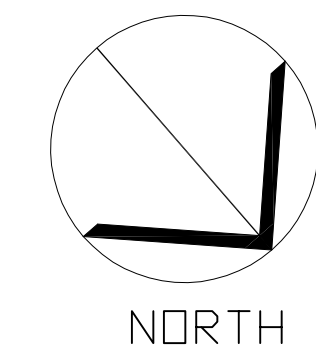

03			
02			
01			
REV.	SUBJECT	DATE	BY

NOTES:

LEGEND:

PROJECT TITLE
PRODUCTIVITY & URBAN RENEWAL
IN EAST JERUSALEM (PURE)
RENOVATION WORKS OF
BUILDING SS004


SHEET TITLE:
**Roof Floor
L.V. Points Plan**

CONSULTANTS:
ZIADAH
ARCHITECTS & ENGINEERS
مهندسون معماريون ومهندسون
POUR
ENGINEERING & PLANNING
CONSULTING ENGINEERS

Scale : 1:100 When Printed A1 Sheet (A0)	Date : 01/11/2017
Design by : ZIADAH CONSULTANTS	Scale : 1:100 centimeters
checked by: ZIADAH CONSULTANTS	Division : ELECTRICAL
Drawn by: ZIADAH CONSULTANTS	SHEET NO. E3-03
Project No:1/16	



دائرة الأوقاف الإسلامية في القدس

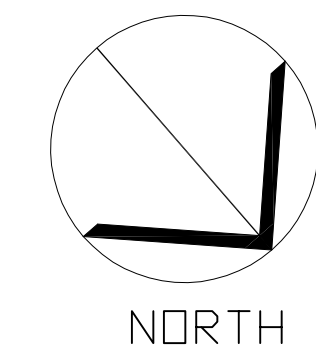

03			
02			
01			
REV.	SUBJECT	DATE	BY


NOTES:

LEGEND:

PROJECT TITLE
PRODUCTIVITY & URBAN RENEWAL
IN EAST JERUSALEM (PURE)
RENOVATION WORKS OF
BUILDING SS004
SHEET TITLE:
**Court Plan
Light Points Plan**

CONSULTANTS:
ZIADAH
ARCHITECTS & ENGINEERS
مهندسون معماريون ومهندسون
POUR
ENGINEERING & PLANNING
CONSULTING ENGINEERS

Scale : 1:100 When Printed A1 Sheet (A0)	Date : 01/11/2017
Design by : ZIADAH CONSULTANTS	checked by: ZIADAH CONSULTANTS
Division : ELECTRICAL	Drawn by: ZIADAH CONSULTANTS
SHEET NO. E4-01	Project No:1/16

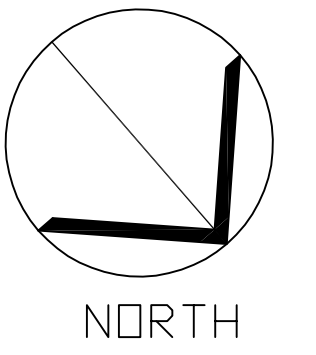

03			
02			
01			
REV.	SUBJECT	DATE	BY

NOTES:

LEGEND:

PROJECT TITLE

PRODUCTIVITY & URBAN RENEWAL
IN EAST JERUSALEM (PURE)

RENOVATION WORKS OF
BUILDING SS004

SHEET TITLE:

Electrical Schematic

CONSULTANTS:

ZIAAH
ARCHITECTS & ENGINEERS
معماران و مهندسان



DOUR ENGINEERING & PLANNING
CONSULTING ENGINEERS

Scale : 1:100 When Printed At Sheet (A0)

Design by :	
ZIADAH CONSULTANTS	


checked by:	D
ZIADAH CONSULTANTS	


Drawn by:	S
ZIADAH CONSULTANTS	

Project No21/16

Date :
01/11/2017

Division :
ELECTRICAL

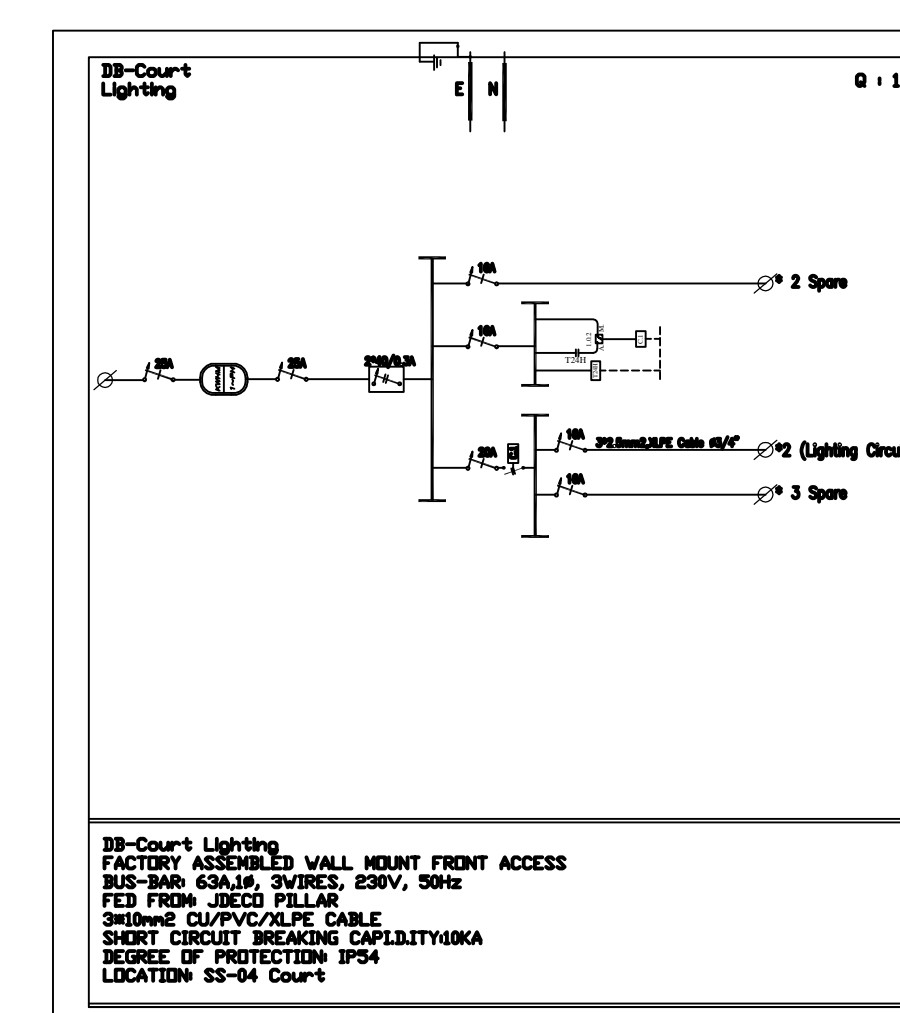

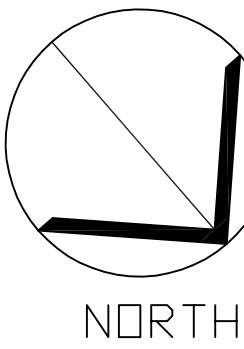

03			
02			
01			
REV.	SUBJECT	DATE	BY

NOTES:


LEGEND:

PROJECT TITLE
PRODUCTIVITY & URBAN RENEWAL
IN EAST JERUSALEM (PURE)
RENOVATION WORKS OF
BUILDING SS004
















SHEET TITLE:

Electrical Details

CONSULTANTS:

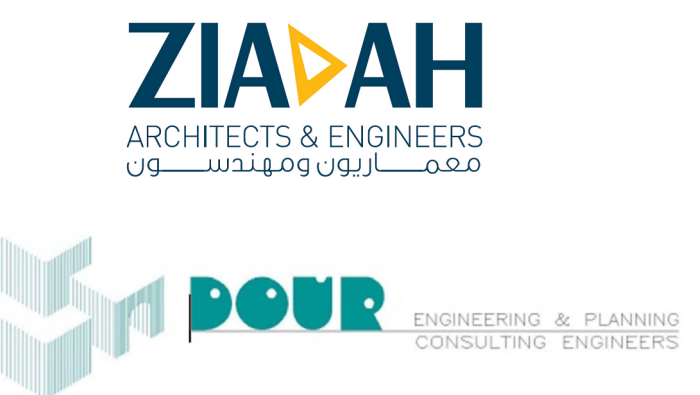


Scale : 1:100 When Printed A1 Sheet (A0)	Date : 01/11/2017
Design by : ZIADAH CONSULTANTS	Division : ELECTRICAL
checked by : ZIADAH CONSULTANTS	SHEET NO. E6-01
Drawn by : ZIADAH CONSULTANTS	
Project No:1/16	

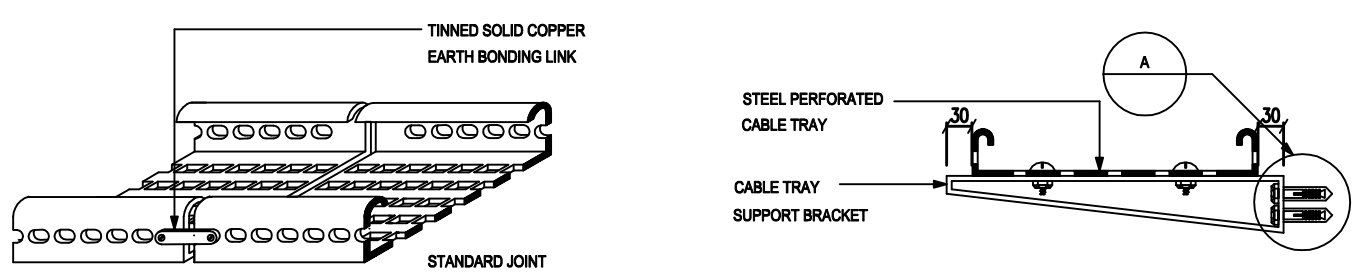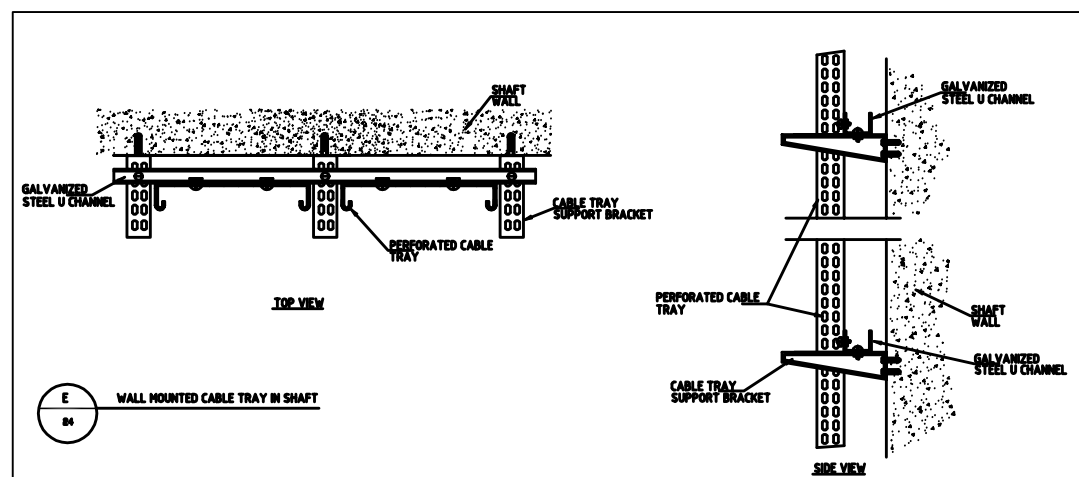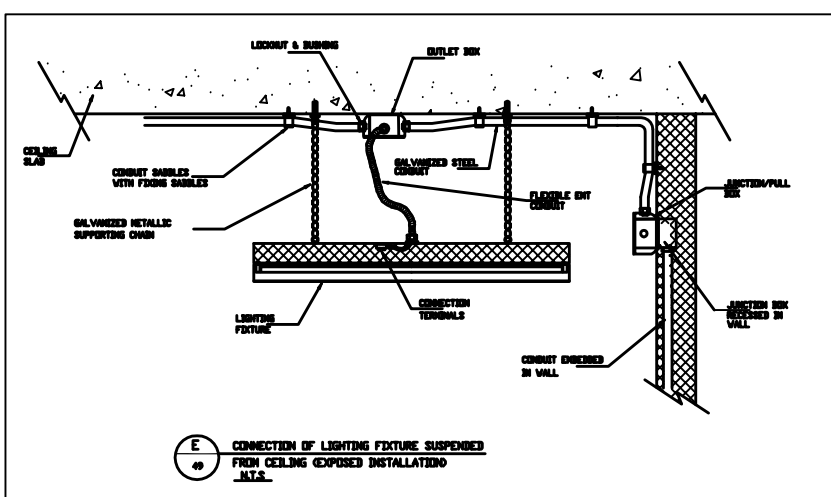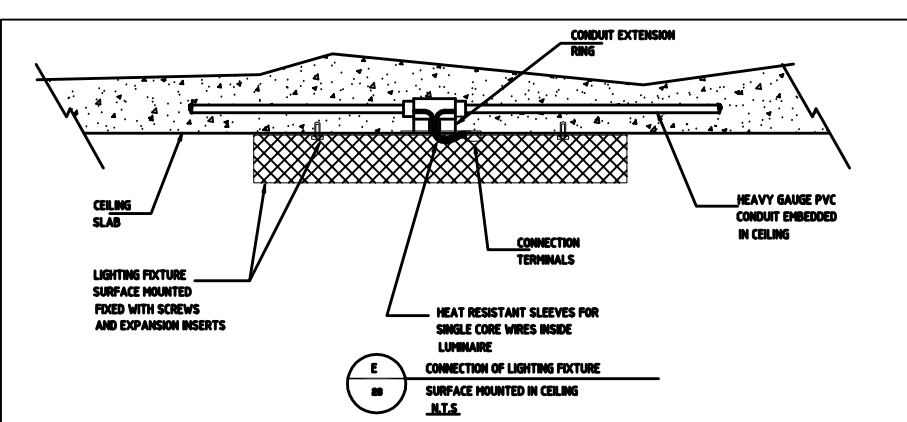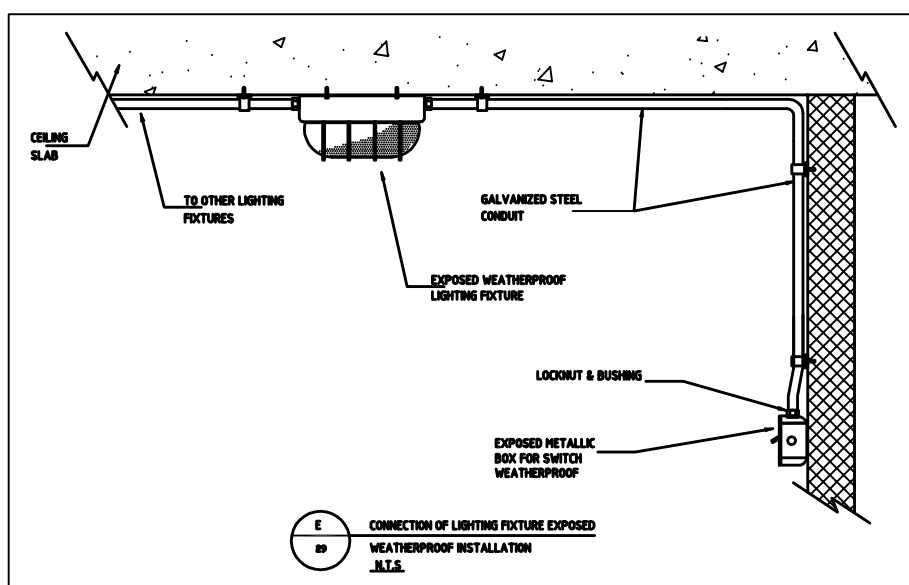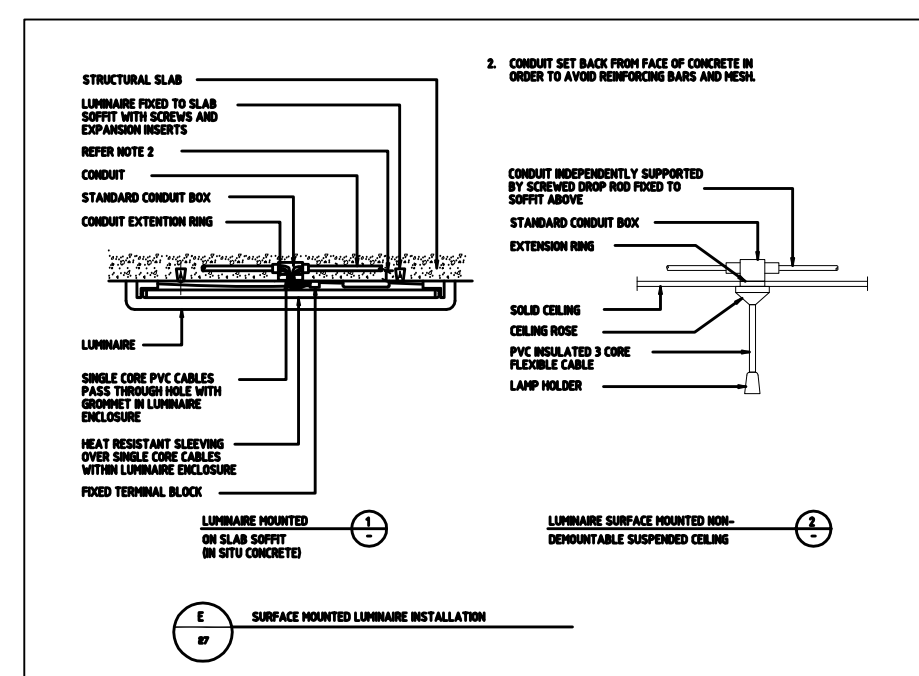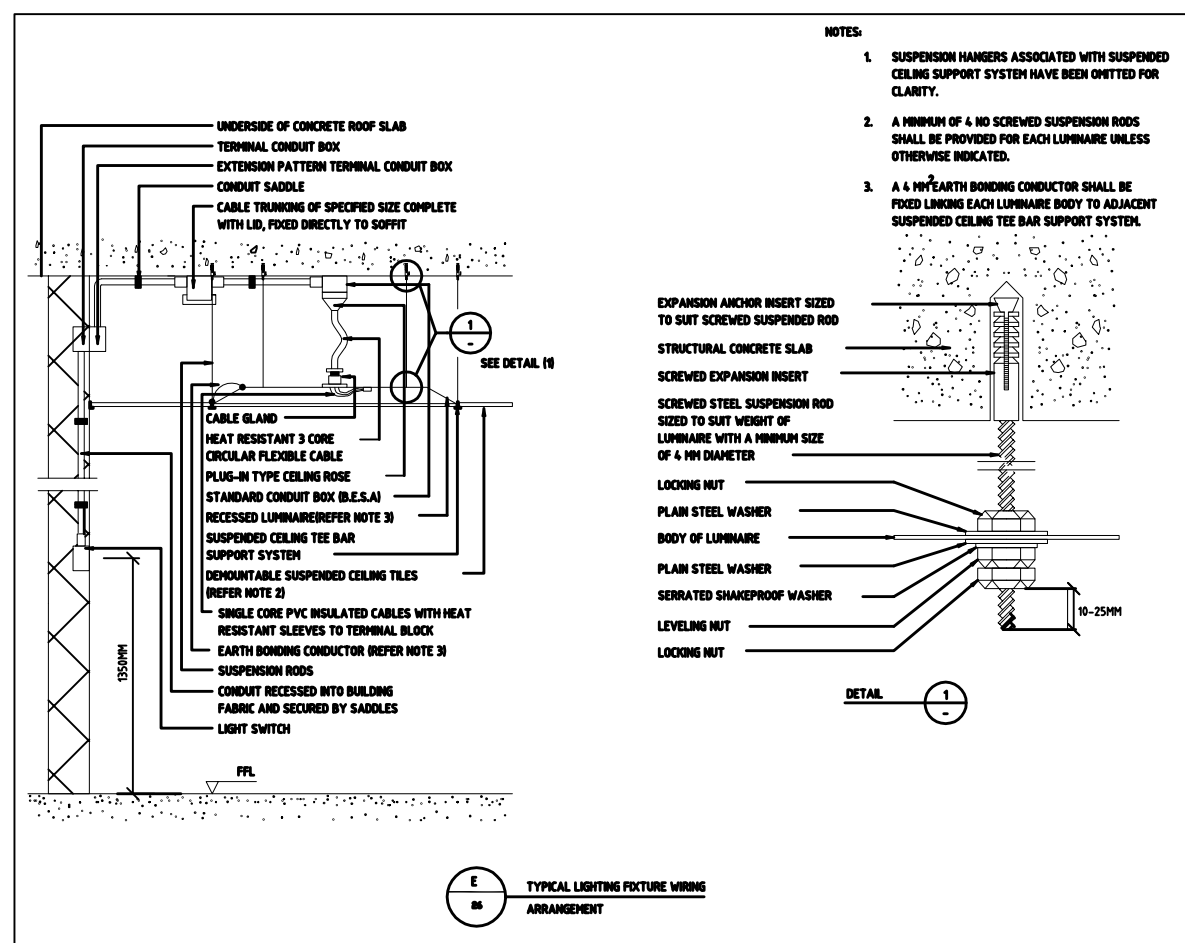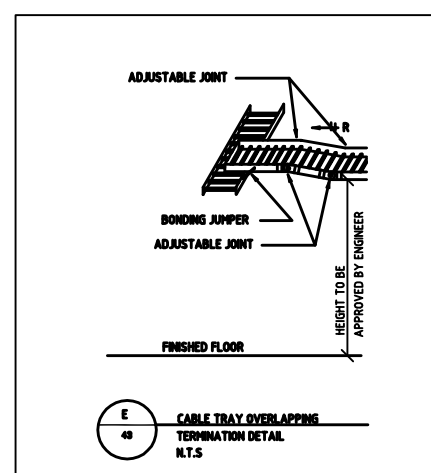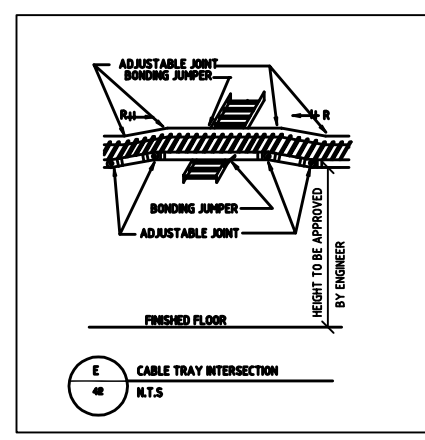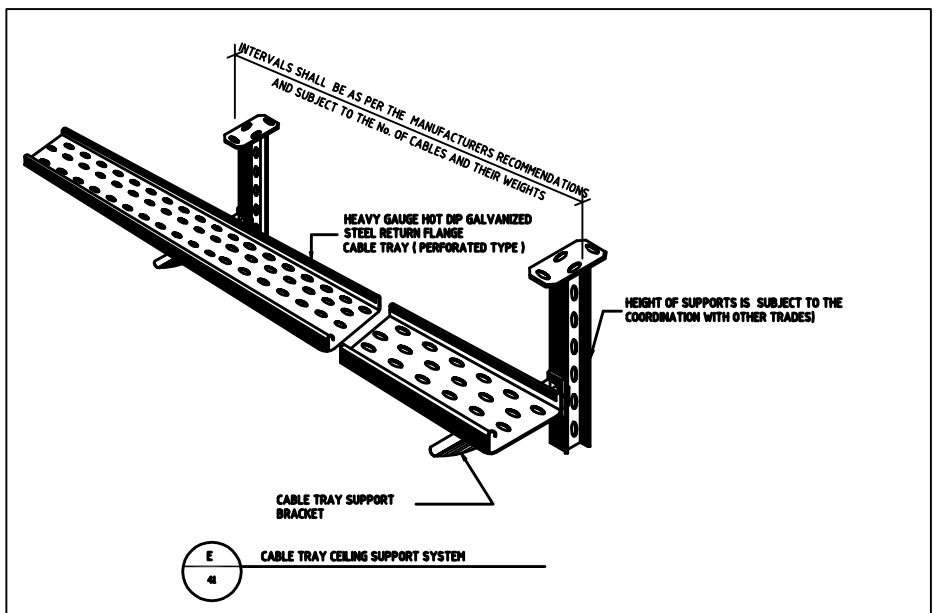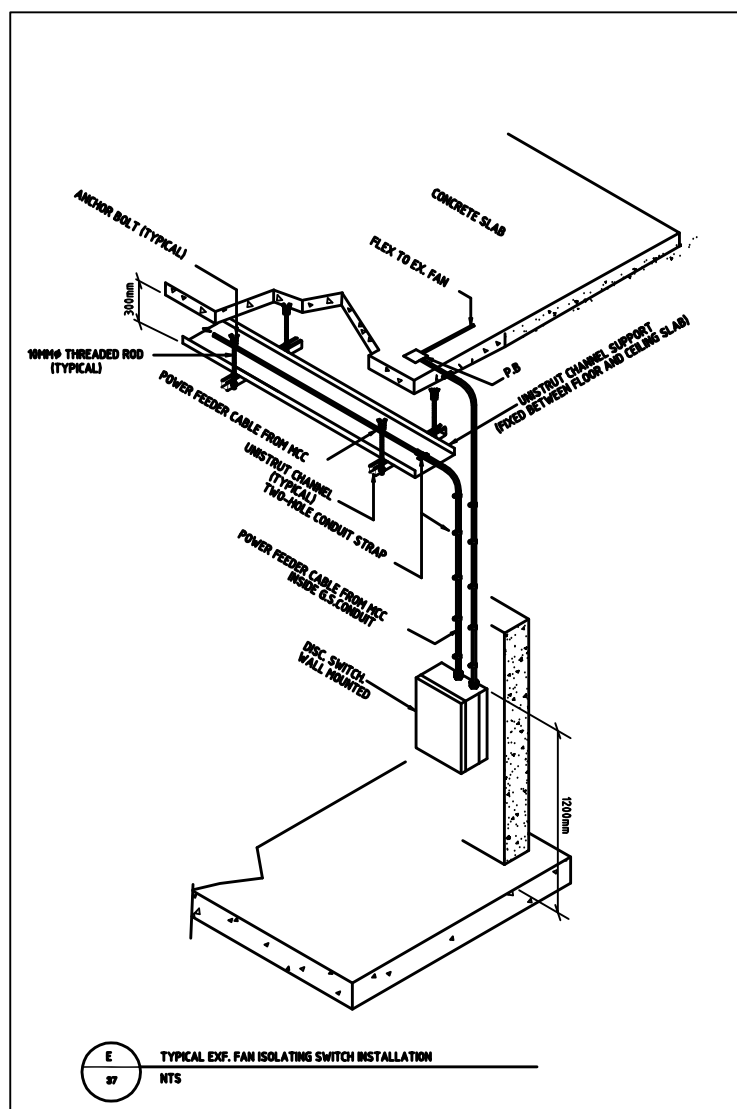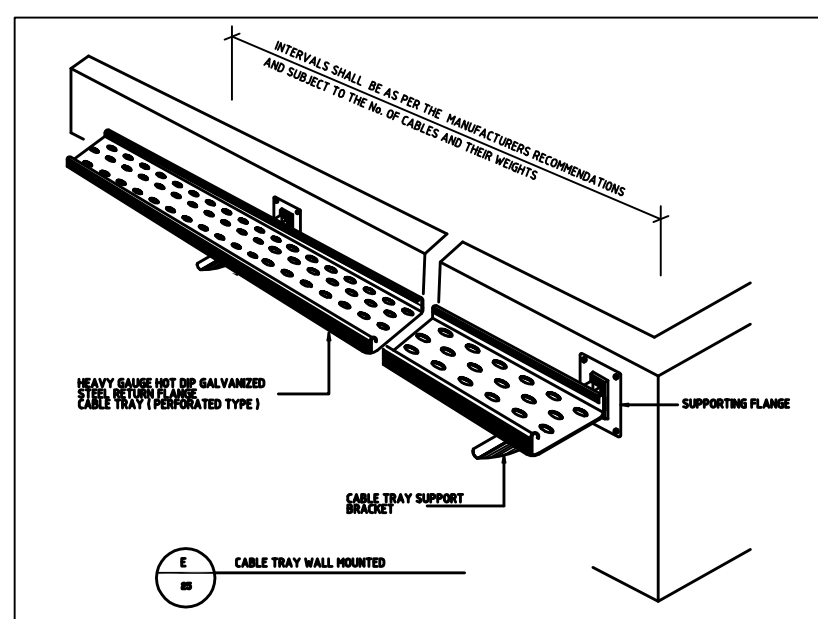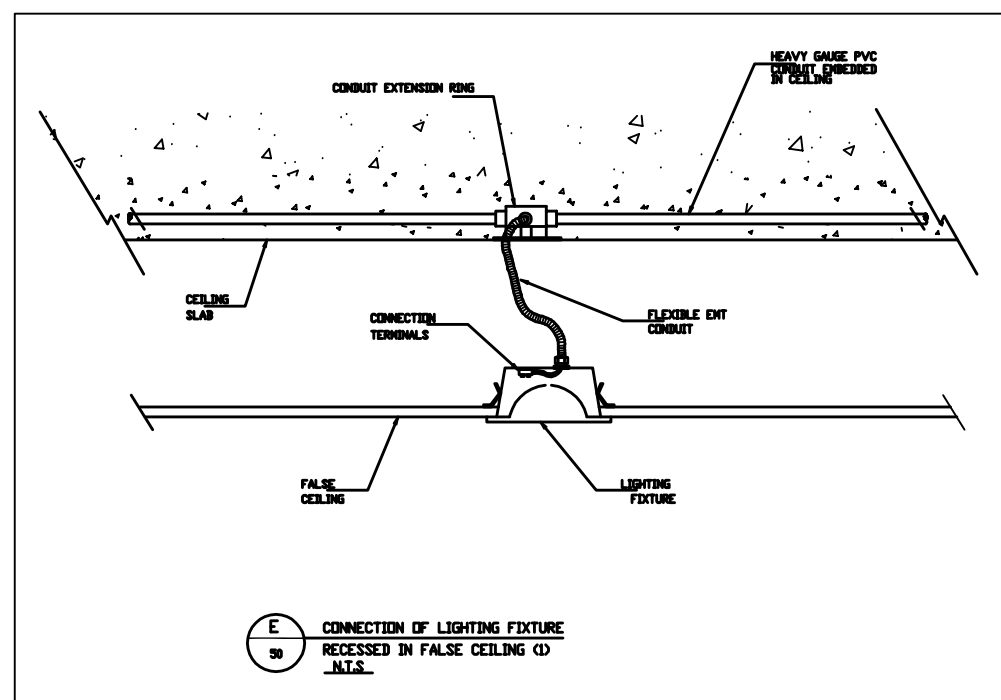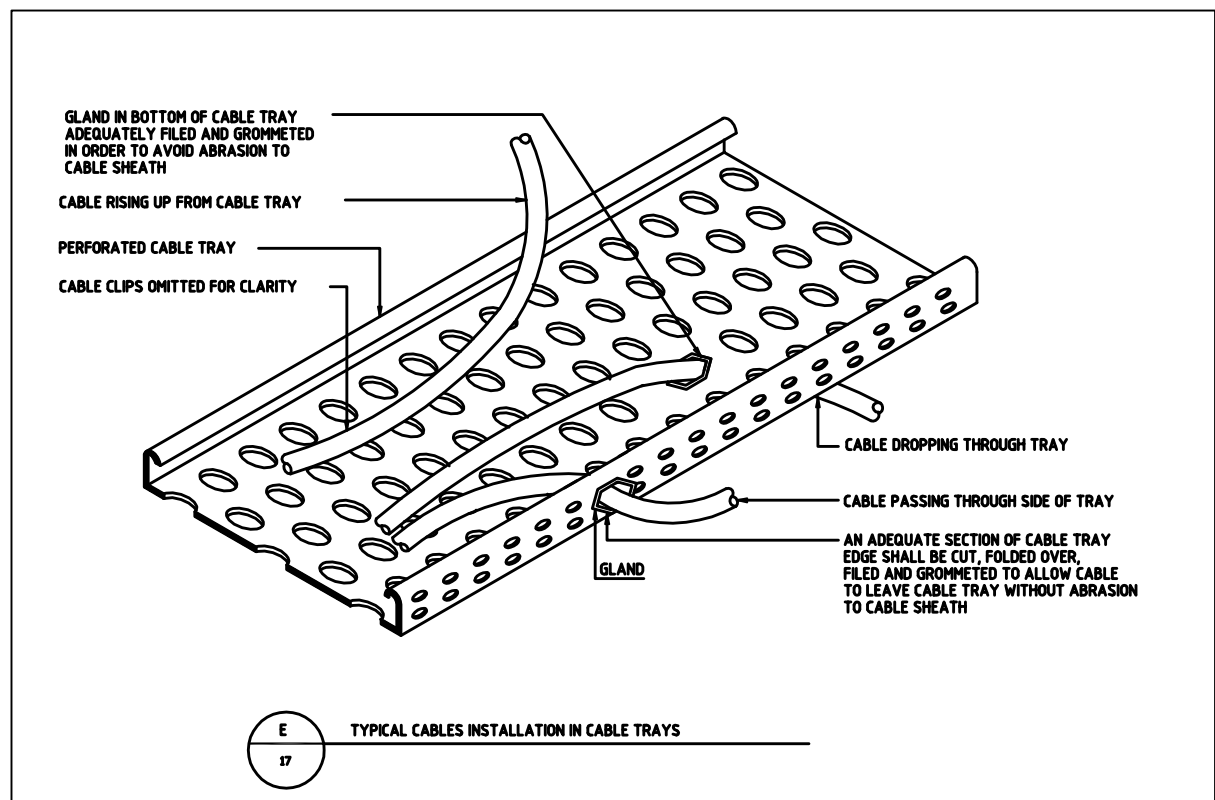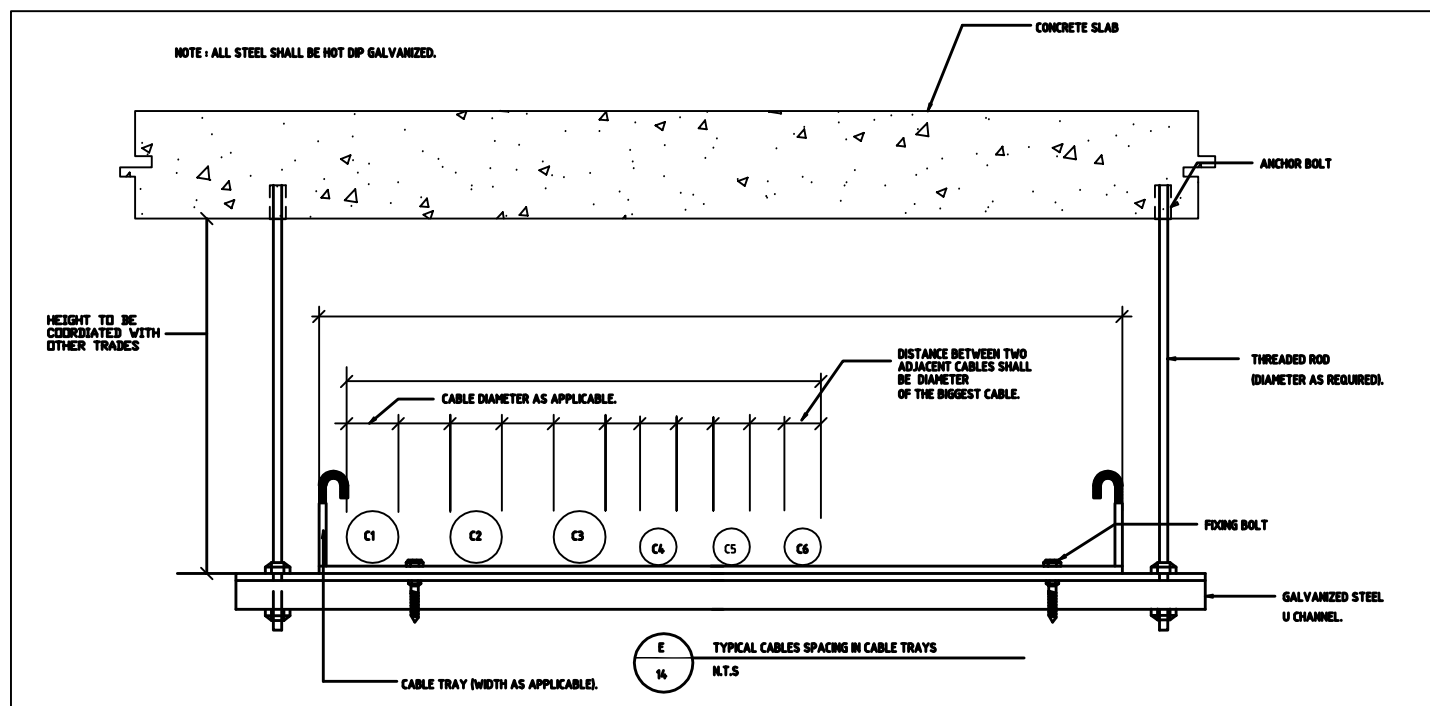


CABLE TRAY BONDING

WALL MOUNTED CABLE TRAY

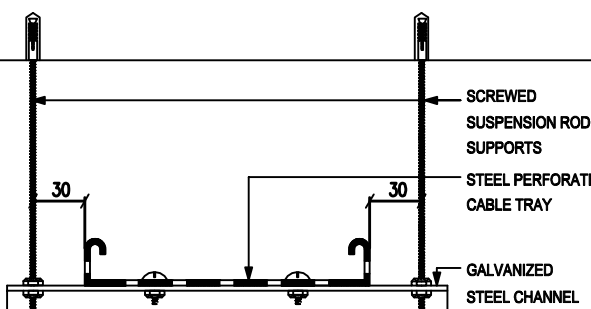

CEILING MOUNTED CABLE TRAY

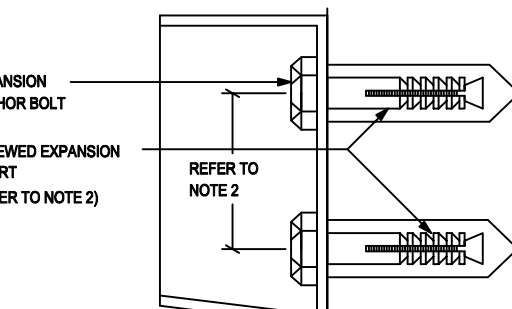


DETAIL (A)


NOTES:

1. EXACT METHOD OF JOINING THE CABLE TRAYS SHALL BE IN ACCORDANCE WITH THE RESPECTIVE MANUFACTURERS RECOMMENDATIONS AND SHALL INCORPORATE ALL NECESSARY PROPRIETARY COMPONENTS.


2. THE PRECISE DIMENSION AND SIZE OF ASSOCIATED EXPANSION AND/OR BOLTS SHALL BE IN ACCORDANCE WITH BOTH THE RESPECTIVE MANUFACTURERS RECOMMENDATIONS AND TO SUIT THE PROPRIETARY COMPONENT.

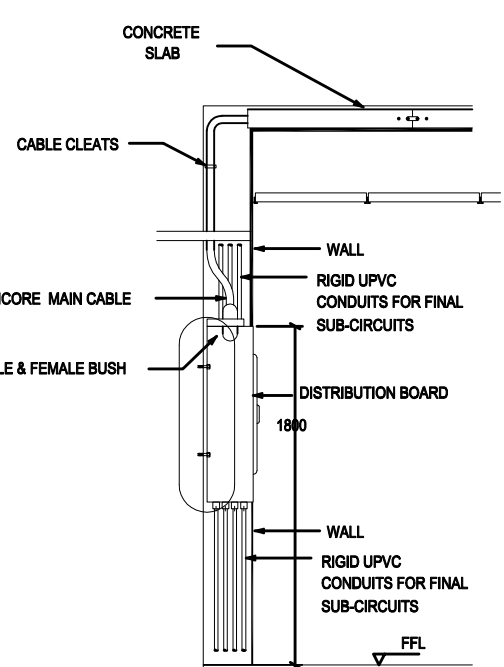


RECESSED DISTRIBUTION BOARD

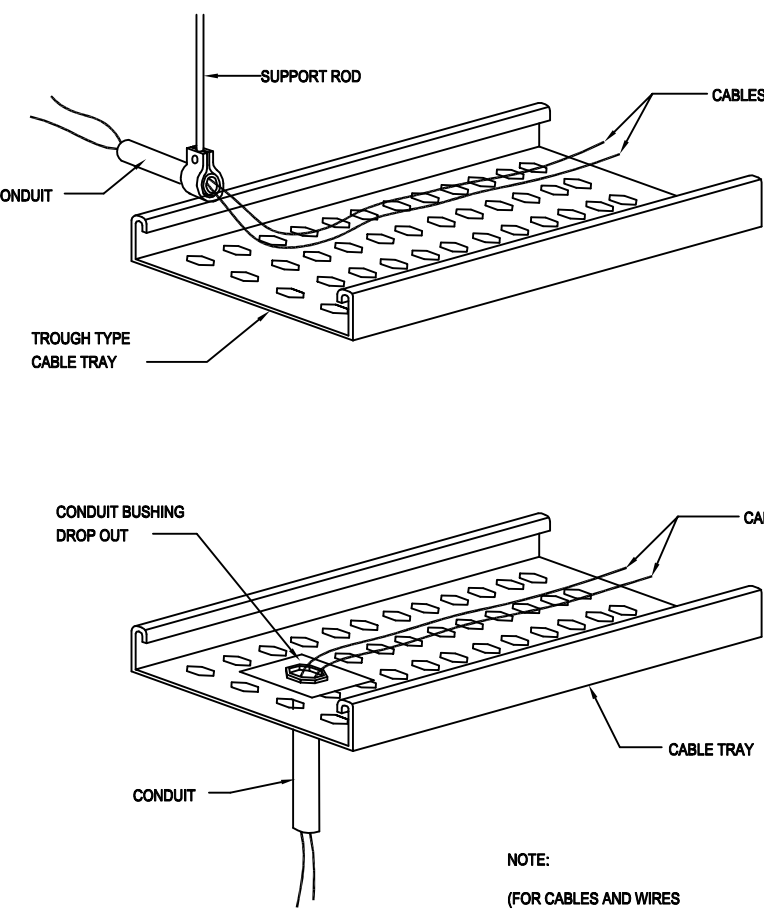


TRANSITION CABLE TRAY TO CONDUIT

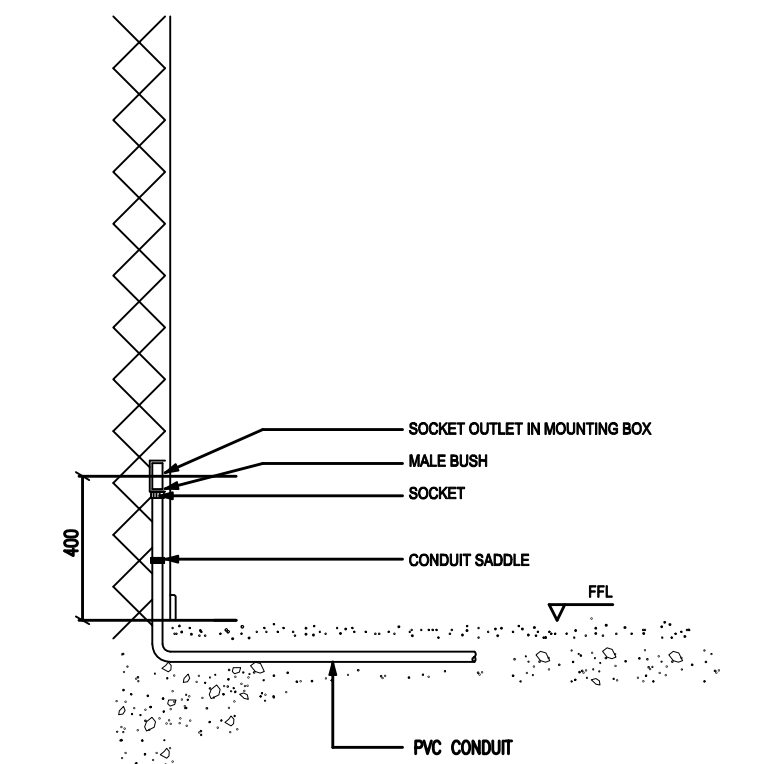


INSTALLATION OF SOCKET OUTLET

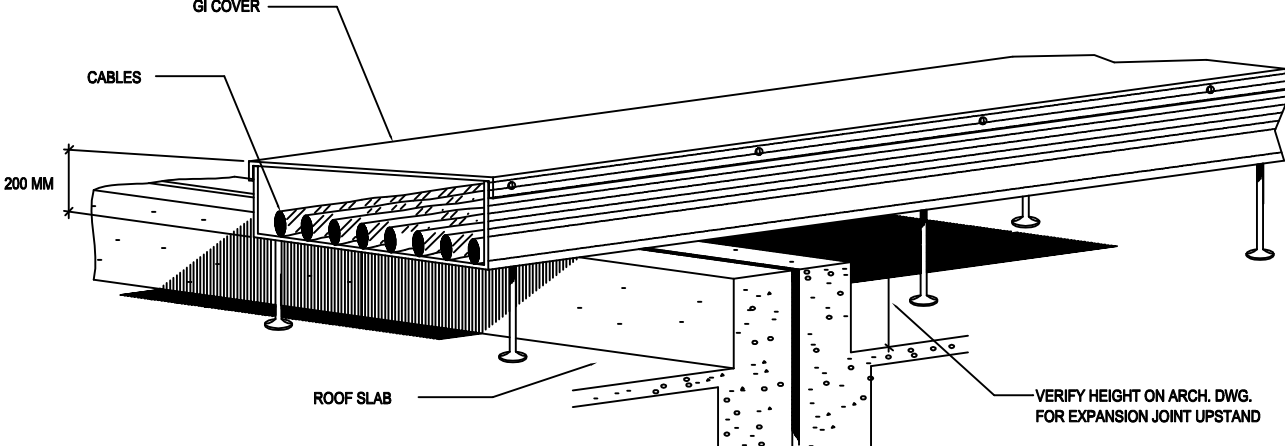


CABLE RACK DETAIL

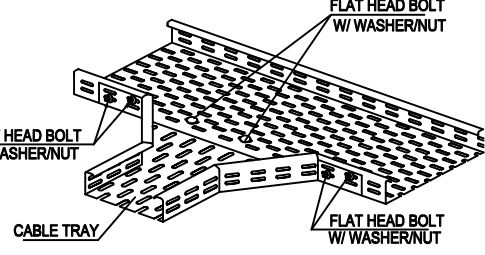


CABLE TRAY BRANCH

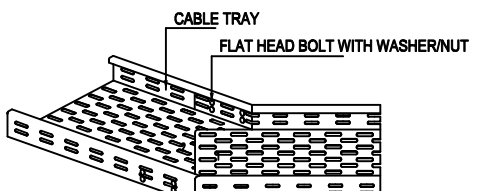

CABLE TRAY HORIZONTAL VARIABLE ANGLE PIECE

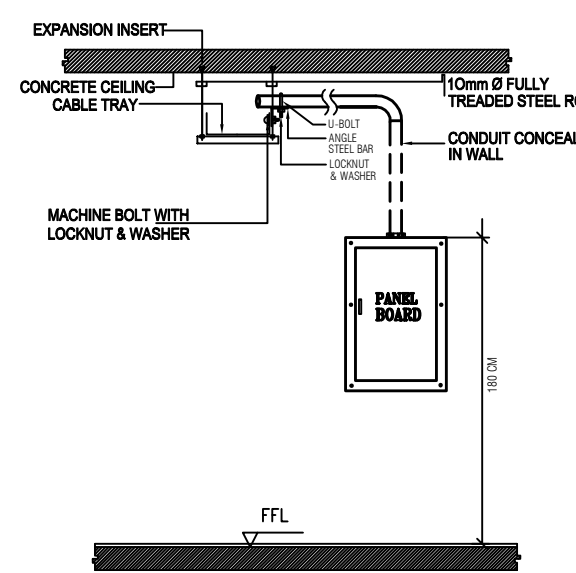

PANEL BOARD TO CABLE TRAY INSTALLATION DETAIL

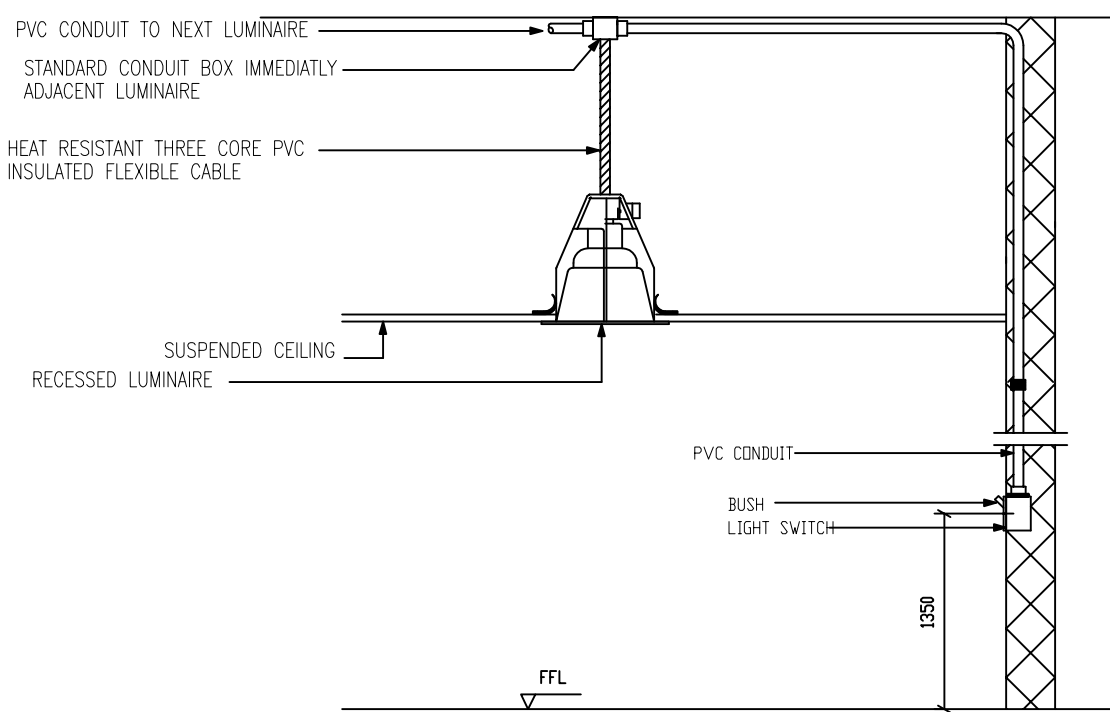

RECESSED LUMINAIRE IN SUSPENDED CEILING