

# Construction of New Small Scale Desalination Units for Education Sector in the Gaza Strip LOT#1

FUNDED BY

The OPEC Fund for International  
Development – OFID

CLIENT:

Ministry Of Education

EMPLOYER

United Nations Development  
Programme  
Programme of Assistance to the  
Palestinian People

UNDP/PAPP

JUN 2018



FUNDED BY :



The OPEC Fund for International Development - OFID

NOTES:

- THE CONTRACTOR SHALL SUBMIT THE MANUFACTURES, CATALOGS, DIMENSIONS, DETAILS AND CONNECTIONS FOR ELECTROCHEMICAL WORKS BEFORE STARTING THE WORKS FOR THE ENGINEER'S APPROVAL.
- THE CONTRACTOR SHALL SUBMIT SHOP DRAWINGS FOR ALL WORKS FOR ENGINEER'S APPROVAL.
- ALL THE WORKS TO BE SUPPLIED, EXECUTED AND TESTED AS PER SPECIFICATIONS, CONDITION'S OF CONTRACT, DRAWINGS AND THE ENGINEER'S APPROVAL.

FOR TENDER ONLY

GRAPHIC SCALE 0 1 2 3 4

NO	DATE	ENG	REVISIONS	

CLIENT:



Ministry Of Education

EMPLOYER:



United Nations Development Programme  
Programme of Assistance to the Palestinian People  
UNDP/PAPP

PROJECT TITLE:

Construction of New Smale Scale Desalination Units for Education Sector in the Gaza Strip

DRAWING TITLE :


LOT# 1 1-Al Shoka School

2-Abassan Elem. Girls School


3-Beni Sohila School

4-Islamic Uni. South Dep.


PREPARED BY	UNDP	SCALE	1:100	DRAWING NO.	D.sh-1
CHECKED BY	UNDP	APPROVED BY	UNDP	SERIAL NO.	0/00
DRAWN BY	UNDP	DATE	JUN 2018		

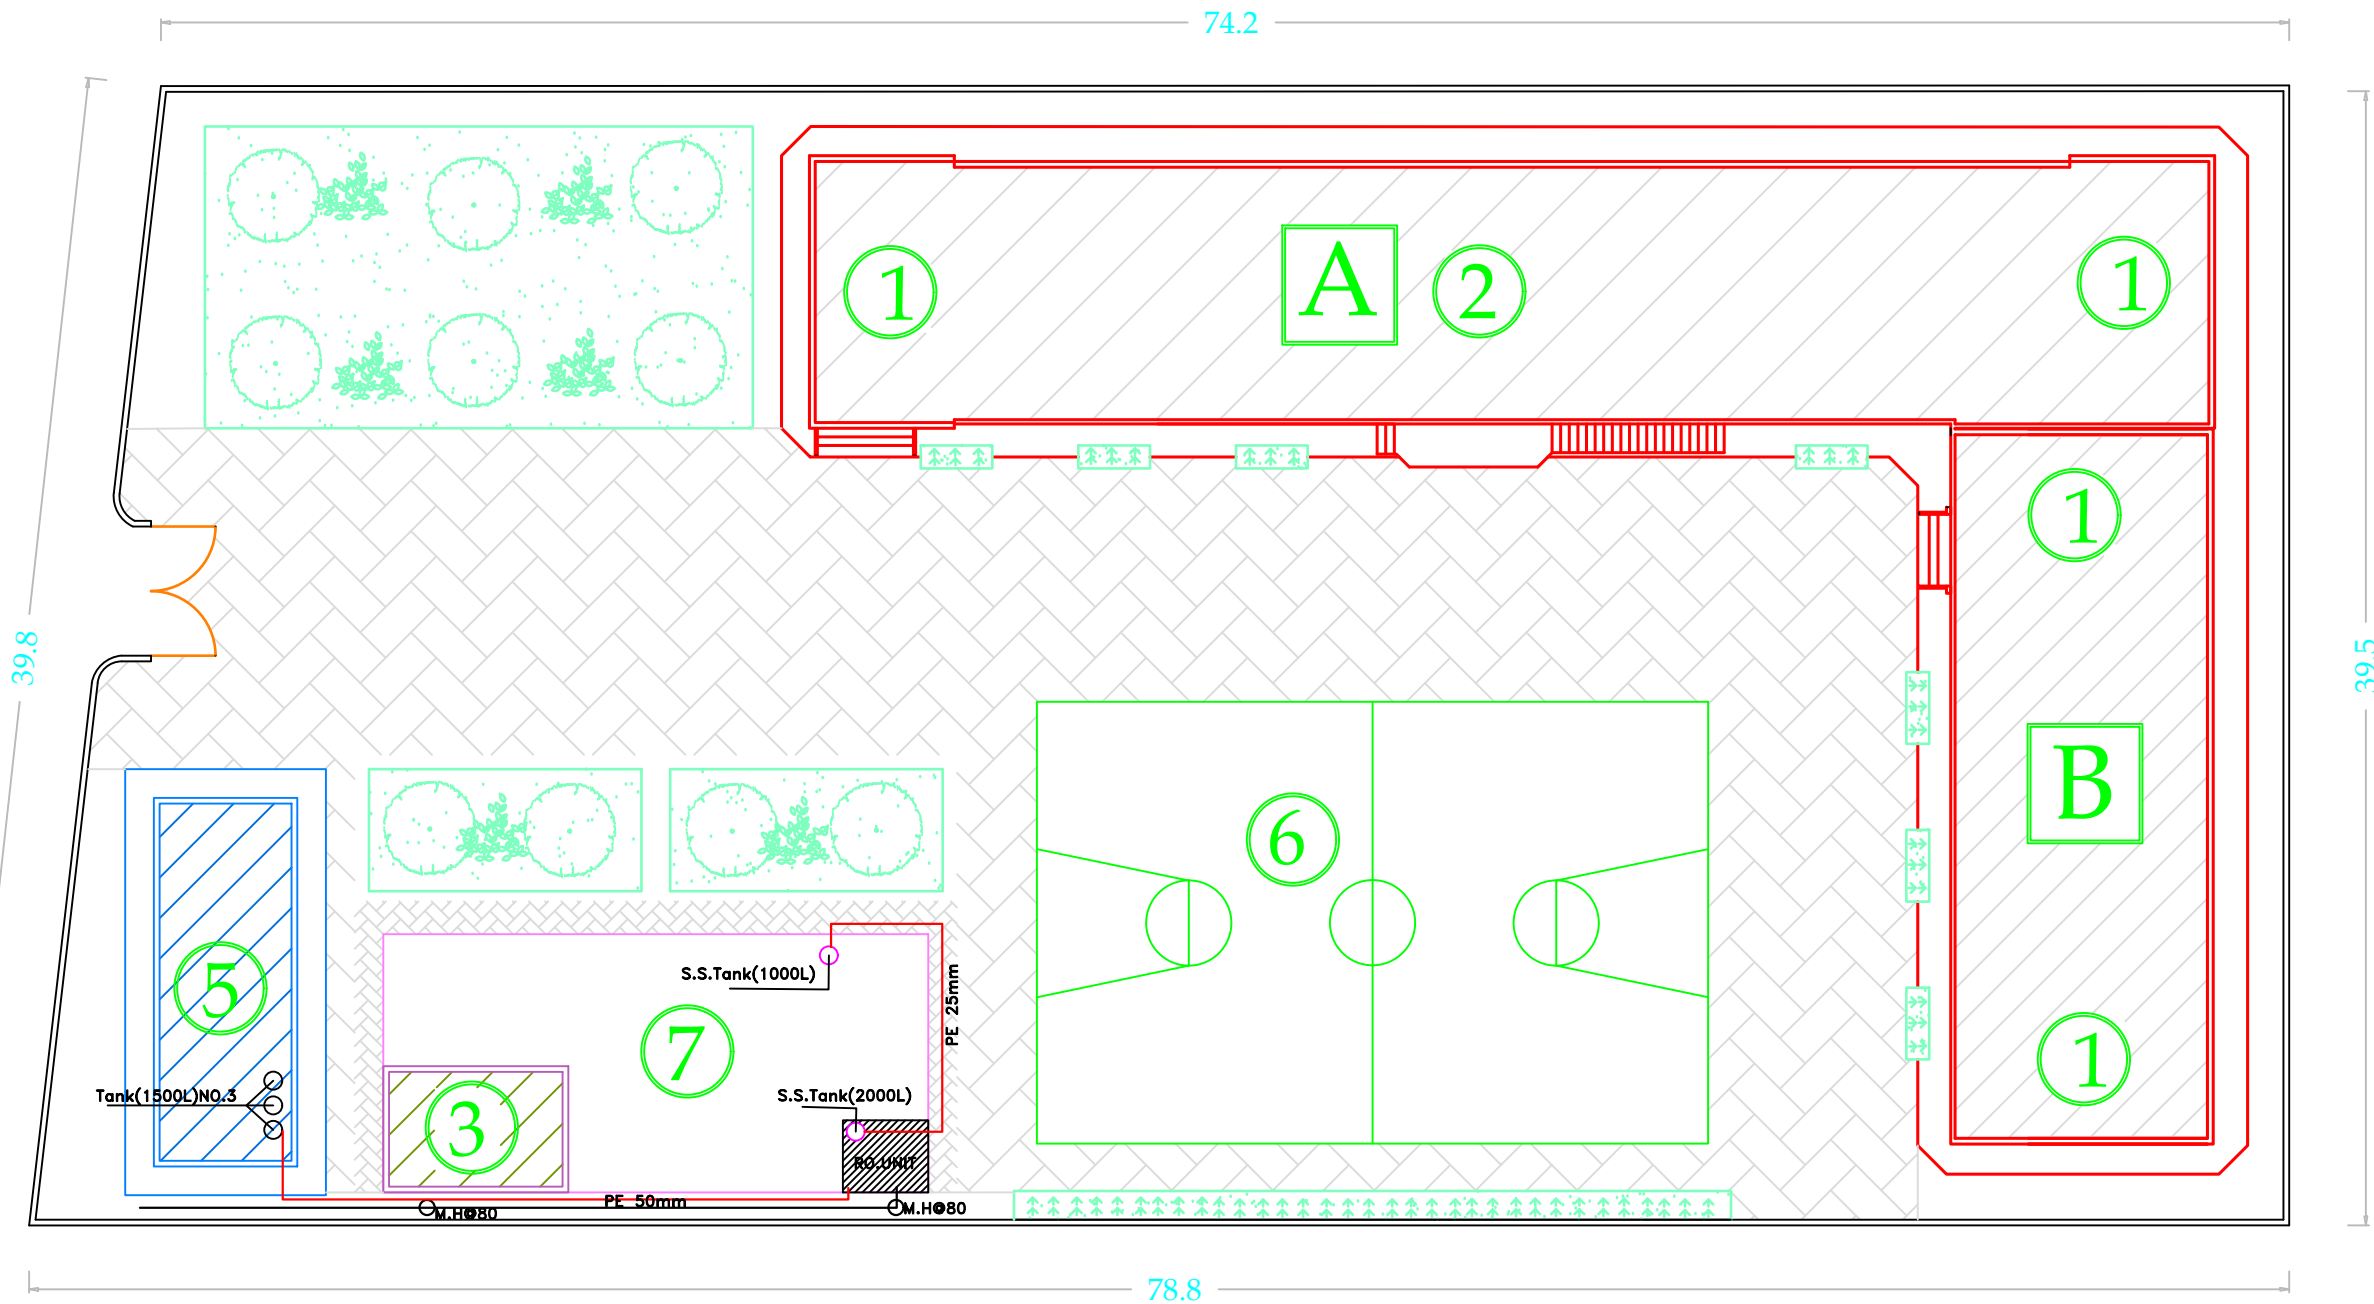

<b>PREPARED BY</b> UNDP	<b>SCALE</b> 1:100	<b>DRAWING NO.</b> D.sh-2
<b>CHECKED BY</b> UNDP	<b>APPROVED BY</b> UNDP	<b>SERIAL NO.</b>
<b>DRAWN BY</b> UNDP	<b>DATE</b> JUN 2018	0/00

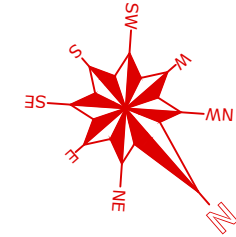

FUNDED BY :

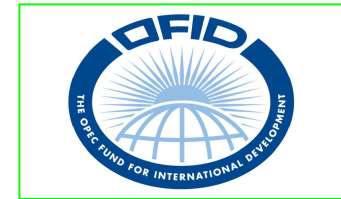

The OPEC Fund for International Development - OFID

NOTES:

- THE CONTRACTOR SHALL SUBMIT THE MANUFACTURES, CATALOGS, DIMENSIONS, DETAILS AND CONNECTIONS FOR ELECTROCHEMICAL WORKS BEFORE STARTING THE WORKS FOR THE ENGINEER'S APPROVAL.
- THE CONTRACTOR SHALL SUBMIT SHOP DRAWINGS FOR ALL WORKS FOR ENGINEER'S APPROVAL.
- ALL THE WORKS TO BE SUPPLIED, EXECUTED AND TESTED AS PER SPECIFICATIONS, CONDITION'S OF CONTRACT, DRAWINGS AND THE ENGINEER'S APPROVAL.

FOR TENDER ONLY

GRAPHIC SCALE 0 1 2 3 4

NO	DATE	ENG	REVISIONS	

CLIENT:



Ministry Of Education

EMPLOYER:



United Nations Development Programme  
Programme of Assistance to the Palestinian People  
UNDP/PAPP

PROJECT TITLE:

Construction of New Smale Scale Desalination Units for Education Sector in the Gaza Strip

DRAWING TITLE :



LOT# 1 1-Al Shoka School

2-Abassan Elem. Girls School

3-Beni Sohila School

4-Islamic Uni. South Dep.

PREPARED BY	UNDP	SCALE	1:100	DRAWING NO.	D.Ab-1
CHECKED BY	UNDP	APPROVED BY	UNDP	SERIAL NO.	0/00
DRAWN BY	UNDP	DATE	JUN 2018		

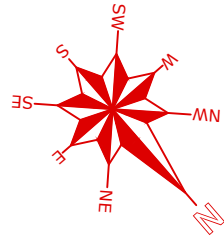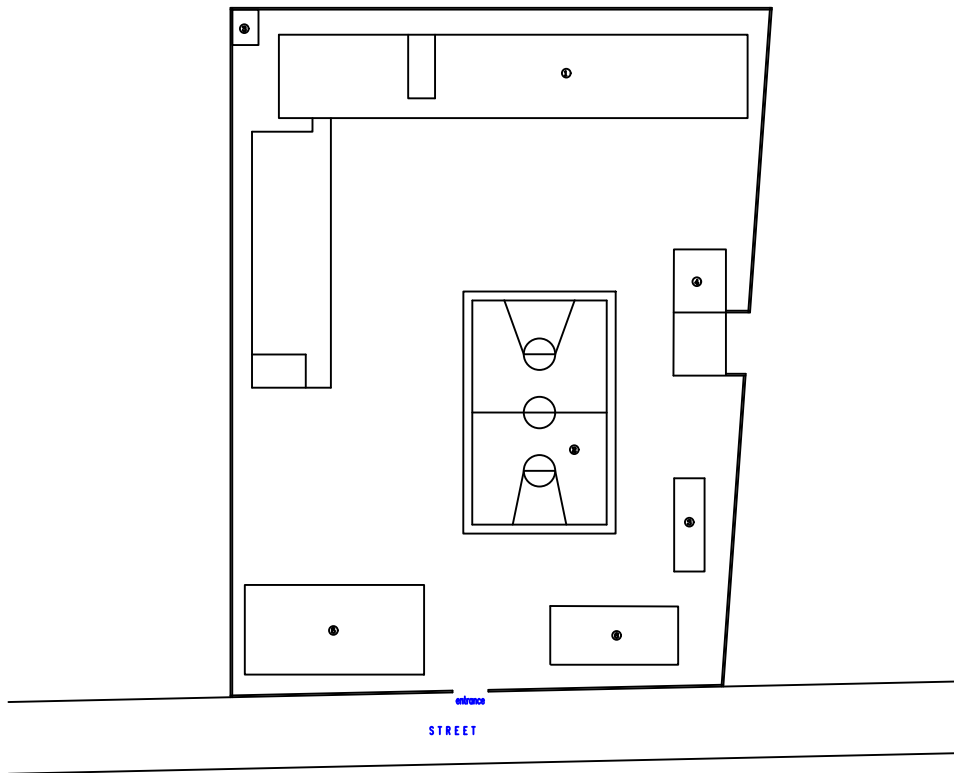

FUNDED BY :



The OPEC Fund for International Development - OFID

NOTES:

- THE CONTRACTOR SHALL SUBMIT THE MANUFACTURES, CATALOGS, DIMENSIONS, DETAILS AND CONNECTIONS FOR ELECTROCHEMICAL WORKS BEFORE STARTING THE WORKS FOR THE ENGINEER'S APPROVAL.
- THE CONTRACTOR SHALL SUBMIT SHOP DRAWINGS FOR ALL WORKS FOR ENGINEER'S APPROVAL.
- ALL THE WORKS TO BE SUPPLIED, EXECUTED AND TESTED AS PER SPECIFICATIONS, CONDITION'S OF CONTRACT, DRAWINGS AND THE ENGINEER'S APPROVAL.

FOR TENDER ONLY

GRAPHIC SCALE 0 1 2 3 4

NO	DATE	ENG	REVISIONS		

CLIENT:



Ministry Of Education

EMPLOYER:



United Nations Development Programme  
Programme of Assistance to the Palestinian People  
UNDP/PAPP

PROJECT TITLE:

Construction of New Smale Scale Desalination Units for Education Sector in the Gaza Strip

DRAWING TITLE :


LOT# 1 1-Al Shoka School

2-Abassan Elem. Girls School

3-Beni Sohila School

4-Islamic Uni. South Dep.

PREPARED BY	UNDP	SCALE	1:100	DRAWING NO.	D.Ab-2
CHECKED BY	UNDP	APPROVED BY	UNDP	SERIAL NO.	0/00
DRAWN BY	UNDP	DATE	JUN 2018		

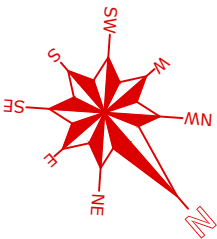

FUNDED BY :



The OPEC Fund for International Development - OFID

NOTES:

- THE CONTRACTOR SHALL SUBMIT THE MANUFACTURES, CATALOGS, DIMENSIONS, DETAILS AND CONNECTIONS FOR ELECTROCHEMICAL WORKS BEFORE STARTING THE WORKS FOR THE ENGINEER'S APPROVAL.
- THE CONTRACTOR SHALL SUBMIT SHOP DRAWINGS FOR ALL WORKS FOR ENGINEER'S APPROVAL.
- ALL THE WORKS TO BE SUPPLIED, EXECUTED AND TESTED AS PER SPECIFICATIONS, CONDITION'S OF CONTRACT, DRAWINGS AND THE ENGINEER'S APPROVAL.

FOR TENDER ONLY

GRAPHIC SCALE 0 1 2 3 4

NO	DATE	ENG	REVISIONS		

CLIENT:



Ministry Of Education

EMPLOYER:



United Nations Development Programme  
Programme of Assistance to the Palestinian People  
UNDP/PAPP

PROJECT TITLE:

Construction of New Smale Scale Desalination Units for Education Sector in the Gaza Strip

DRAWING TITLE :


LOT# 1 1-Al Shoka School



2-Abassan Elem. Girls School

3-Beni Sohila School

4-Islamic Uni. South Dep.

PREPARED BY	UNDP	SCALE	1:100	DRAWING NO.	D.Ab-3
CHECKED BY	UNDP	APPROVED BY	UNDP	SERIAL NO.	0/00
DRAWN BY	UNDP	DATE	JUN 2018		

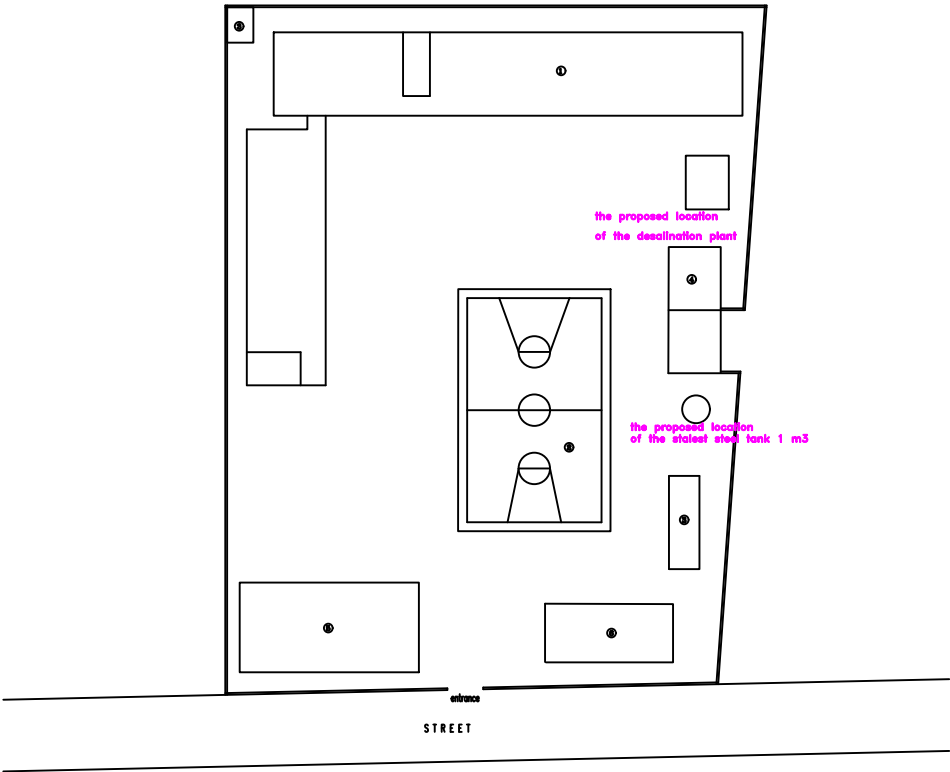

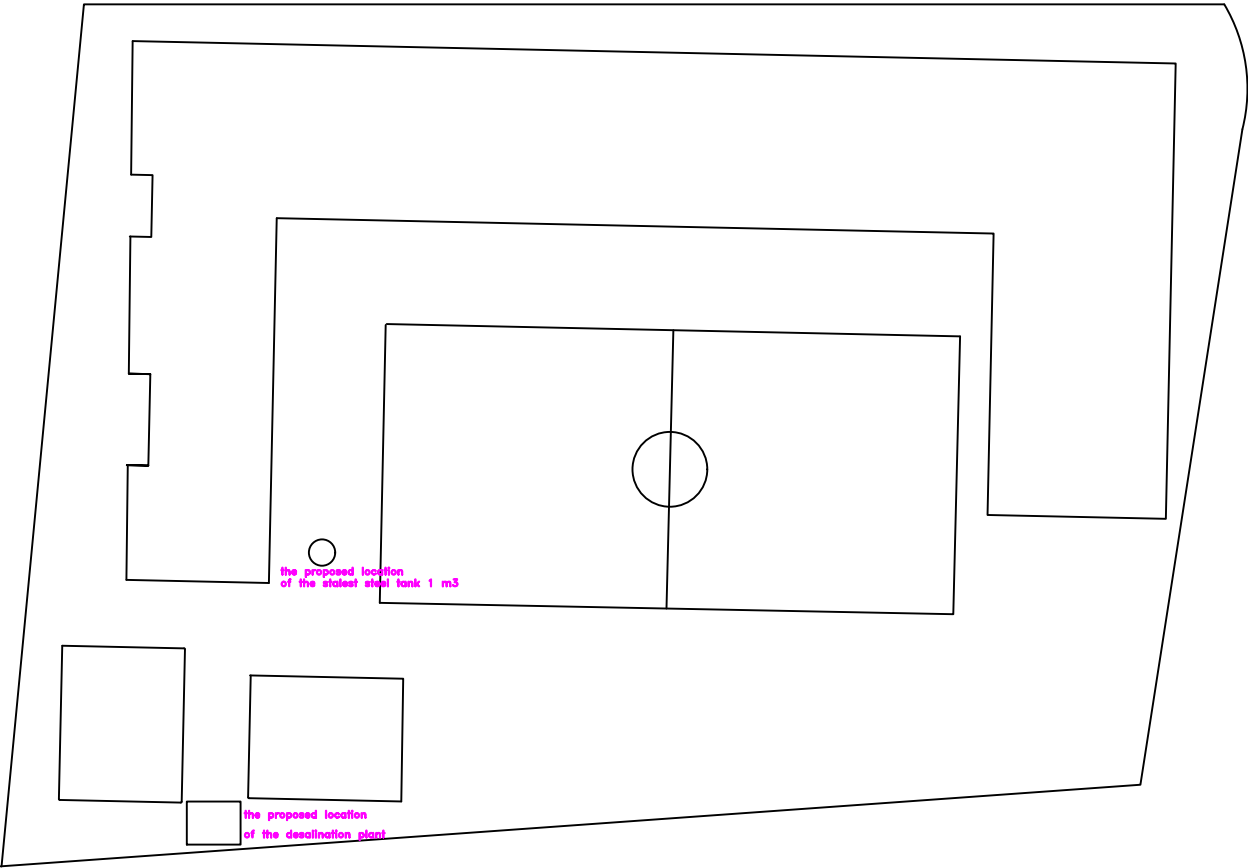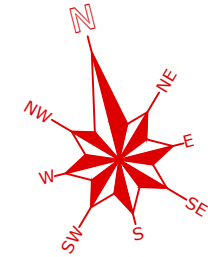

FUNDED BY :



The OPEC Fund for International Development - OFID

NOTES:

- THE CONTRACTOR SHALL SUBMIT THE MANUFACTURES, CATALOGS, DIMENSIONS, DETAILS AND CONNECTIONS FOR ELECTROCHEMICAL WORKS BEFORE STARTING THE WORKS FOR THE ENGINEER'S APPROVAL.
- THE CONTRACTOR SHALL SUBMIT SHOP DRAWINGS FOR ALL WORKS FOR ENGINEER'S APPROVAL.
- ALL THE WORKS TO BE SUPPLIED, EXECUTED AND TESTED AS PER SPECIFICATIONS, CONDITION'S OF CONTRACT, DRAWINGS AND THE ENGINEER'S APPROVAL.

FOR TENDER ONLY

GRAPHIC SCALE 0 1 2 3 4

NO	DATE	ENG	REVISIONS	

CLIENT:



Ministry Of Education

EMPLOYER:



United Nations Development Programme  
Programme of Assistance to the Palestinian People  
UNDP/PAPP

PROJECT TITLE:

Construction of New Smale Scale Desalination Units for Education Sector in the Gaza Strip

DRAWING TITLE :

LOT# 1 1-Al Shoka School


2-Abassan Elem. Girls School

3-Beni Sohila School

4-Islamic Uni. South Dep.

PREPARED BY	UNDP	SCALE	1:100	DRAWING NO.	D.Be-1
CHECKED BY	UNDP	APPROVED BY	UNDP	SERIAL NO.	0/00
DRAWN BY	UNDP	DATE	JUN 2018		



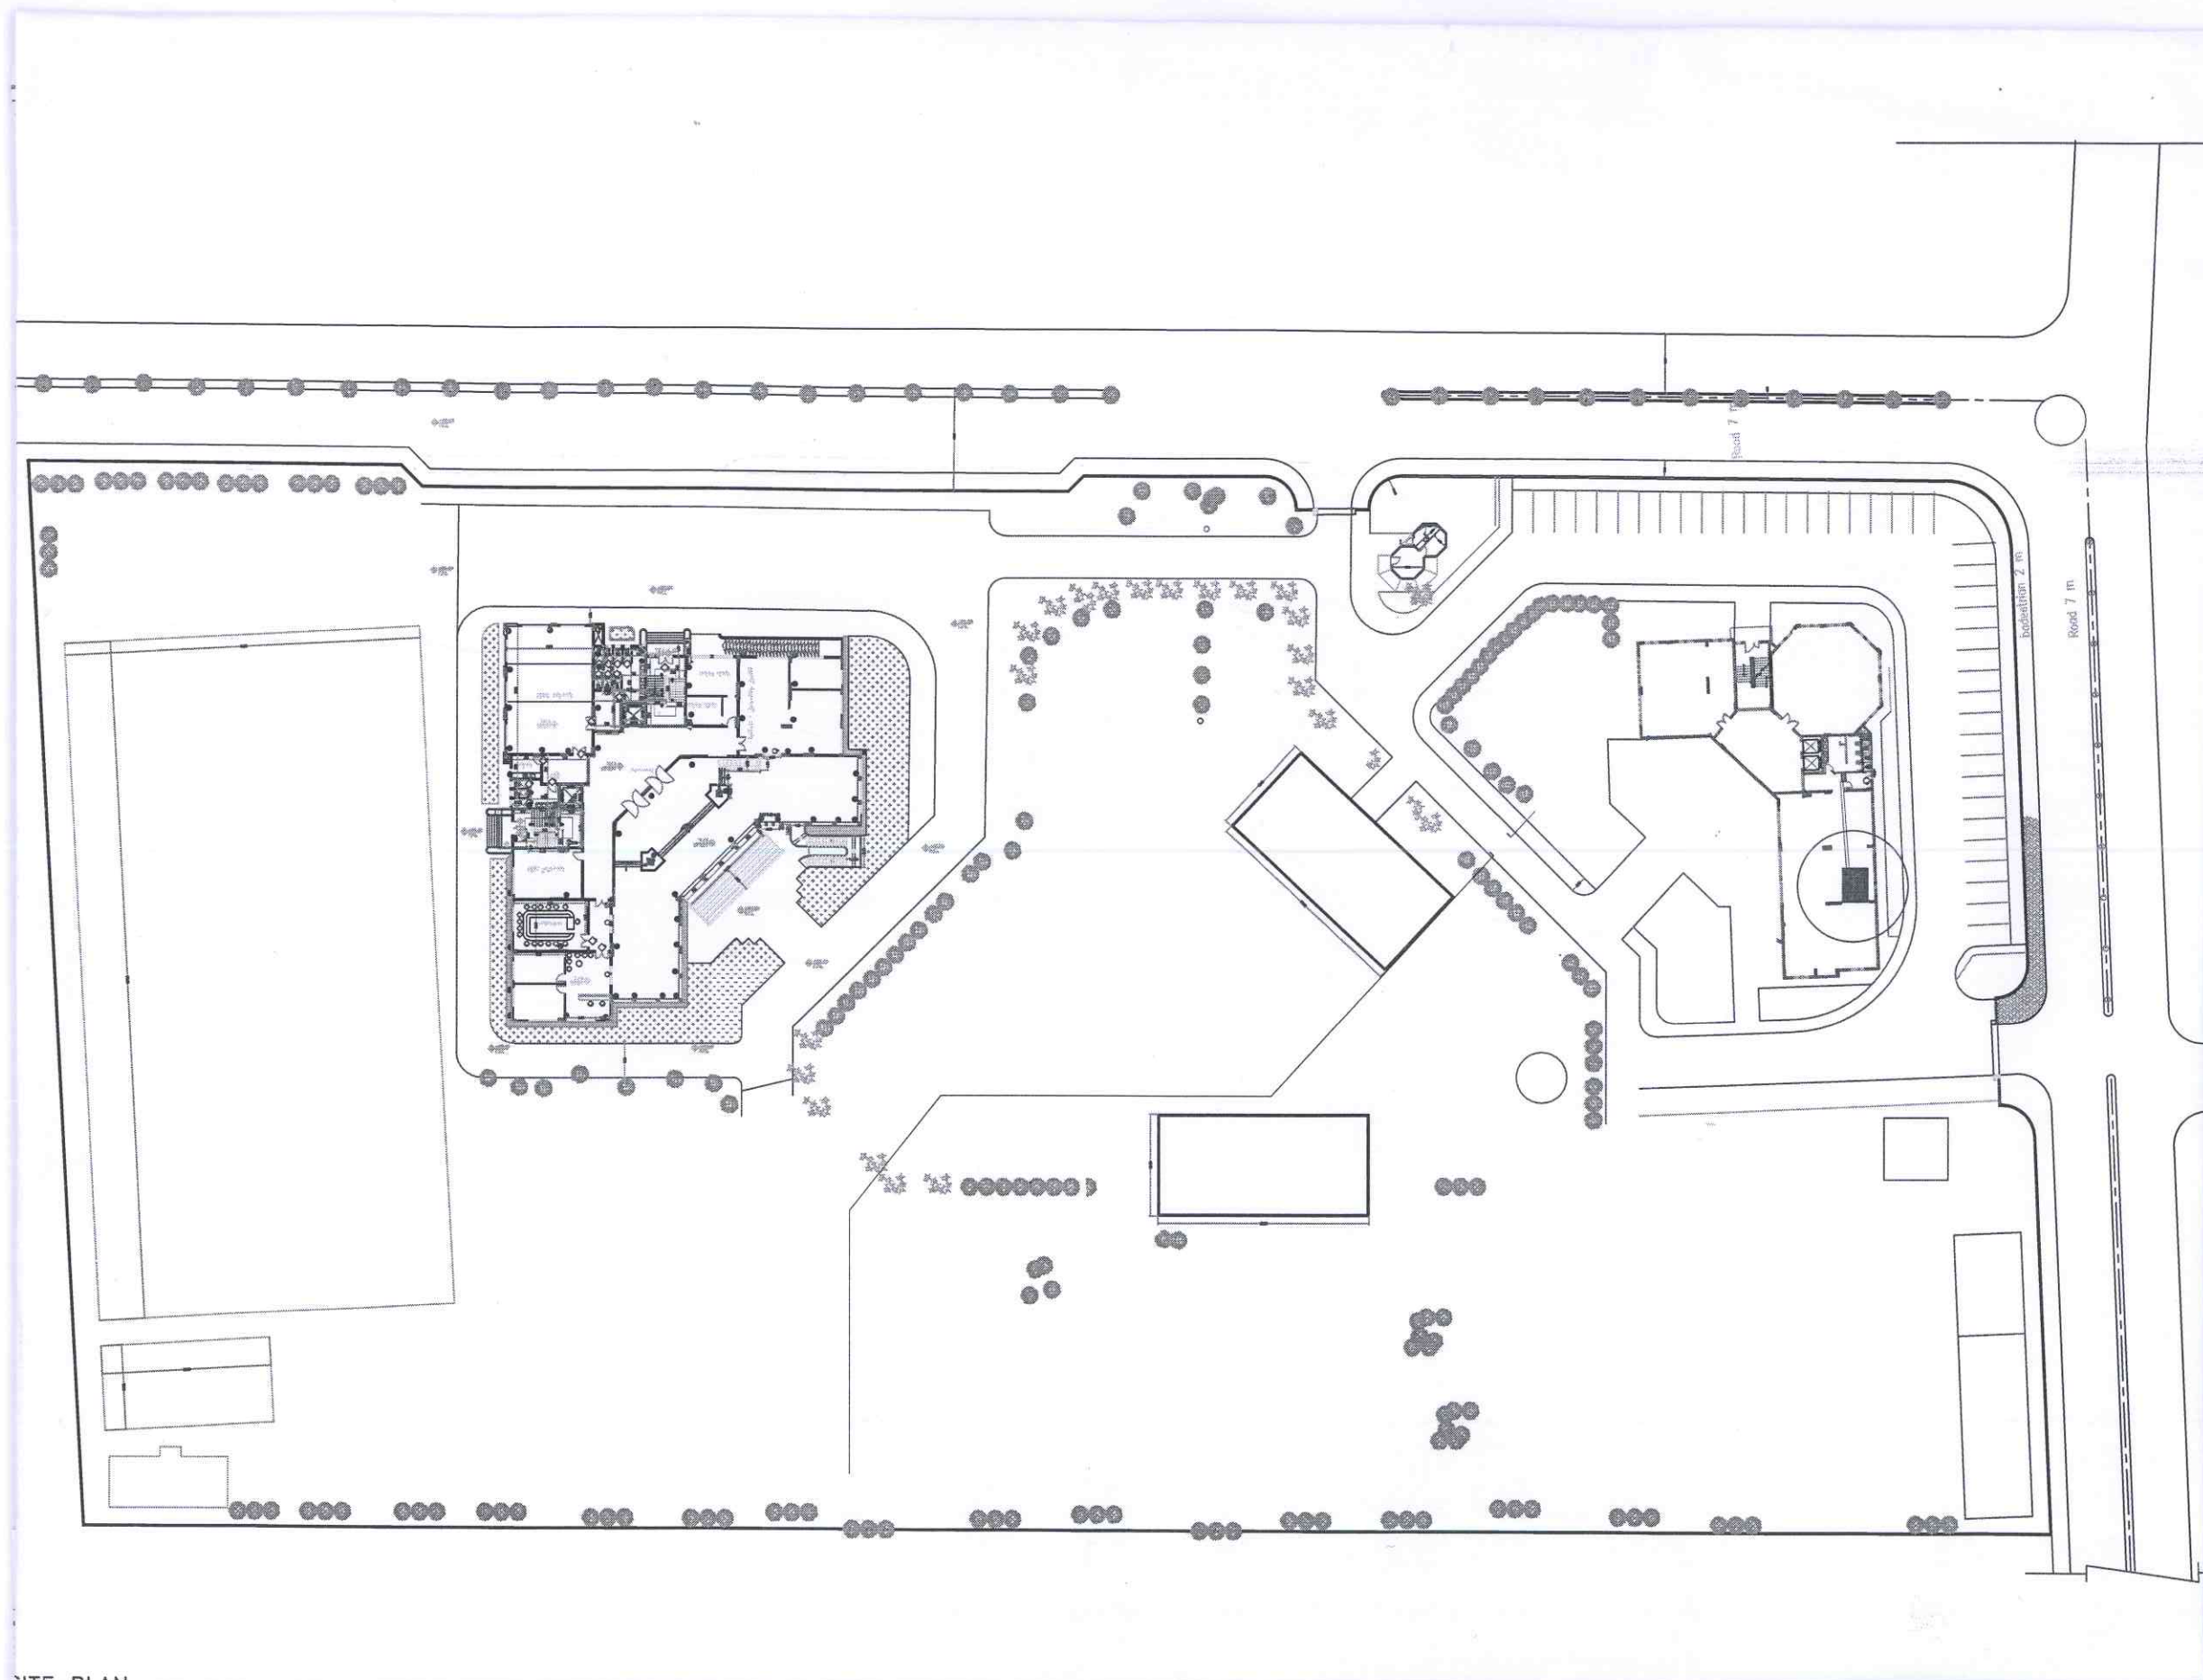

SITE PLAN

FUNDED BY :



The OPEC Fund for International Development - OFID

# NOTES:

- THE CONTRACTOR SHALL SUBMIT THE MANUFACTURES, CATALOGS, DIMENSIONS, DETAILS AND CONNECTIONS FOR ELECTROCHEMICAL WORKS BEFORE STARTING THE WORKS FOR THE ENGINEER'S APPROVAL.
- THE CONTRACTOR SHALL SUBMIT SHOP DRAWINGS FOR ALL WORKS FOR ENGINEER'S APPROVAL.
- ALL THE WORKS TO BE SUPPLIED, EXECUTED AND TESTED AS PER SPECIFICATIONS, CONDITION'S OF CONTRACT, DRAWINGS AND THE ENGINEER'S APPROVAL.

FOR TENDER ONLY

GRAPHIC SCALE 0 1 2 3 4

NO	DATE	ENG	REVISIONS

## CLIENT:



Ministry Of Education

## EMPLOYER:



United Nations Development Programme  
Programme of Assistance to the Palestinian People  
UNDP/PAPP

## PROJECT TITLE:

Construction of New Small Scale Desalination Units for Education Sector in the Gaza Strip

## DRAWING TITLE:

LOT#1 1-Al Shoka School


2-Abassan Elem. Girls School

3-Beni Sohila School

4-Islamic Uni. South Dep.

PREPARED BY UNDP	SCALE 1:100	DRAWING NO. D.Jug-1
CHECKED BY UNDP	APPROVED BY UNDP	SERIAL NO.
DRAWN BY UNDP	DATE JUN 2018	0/00



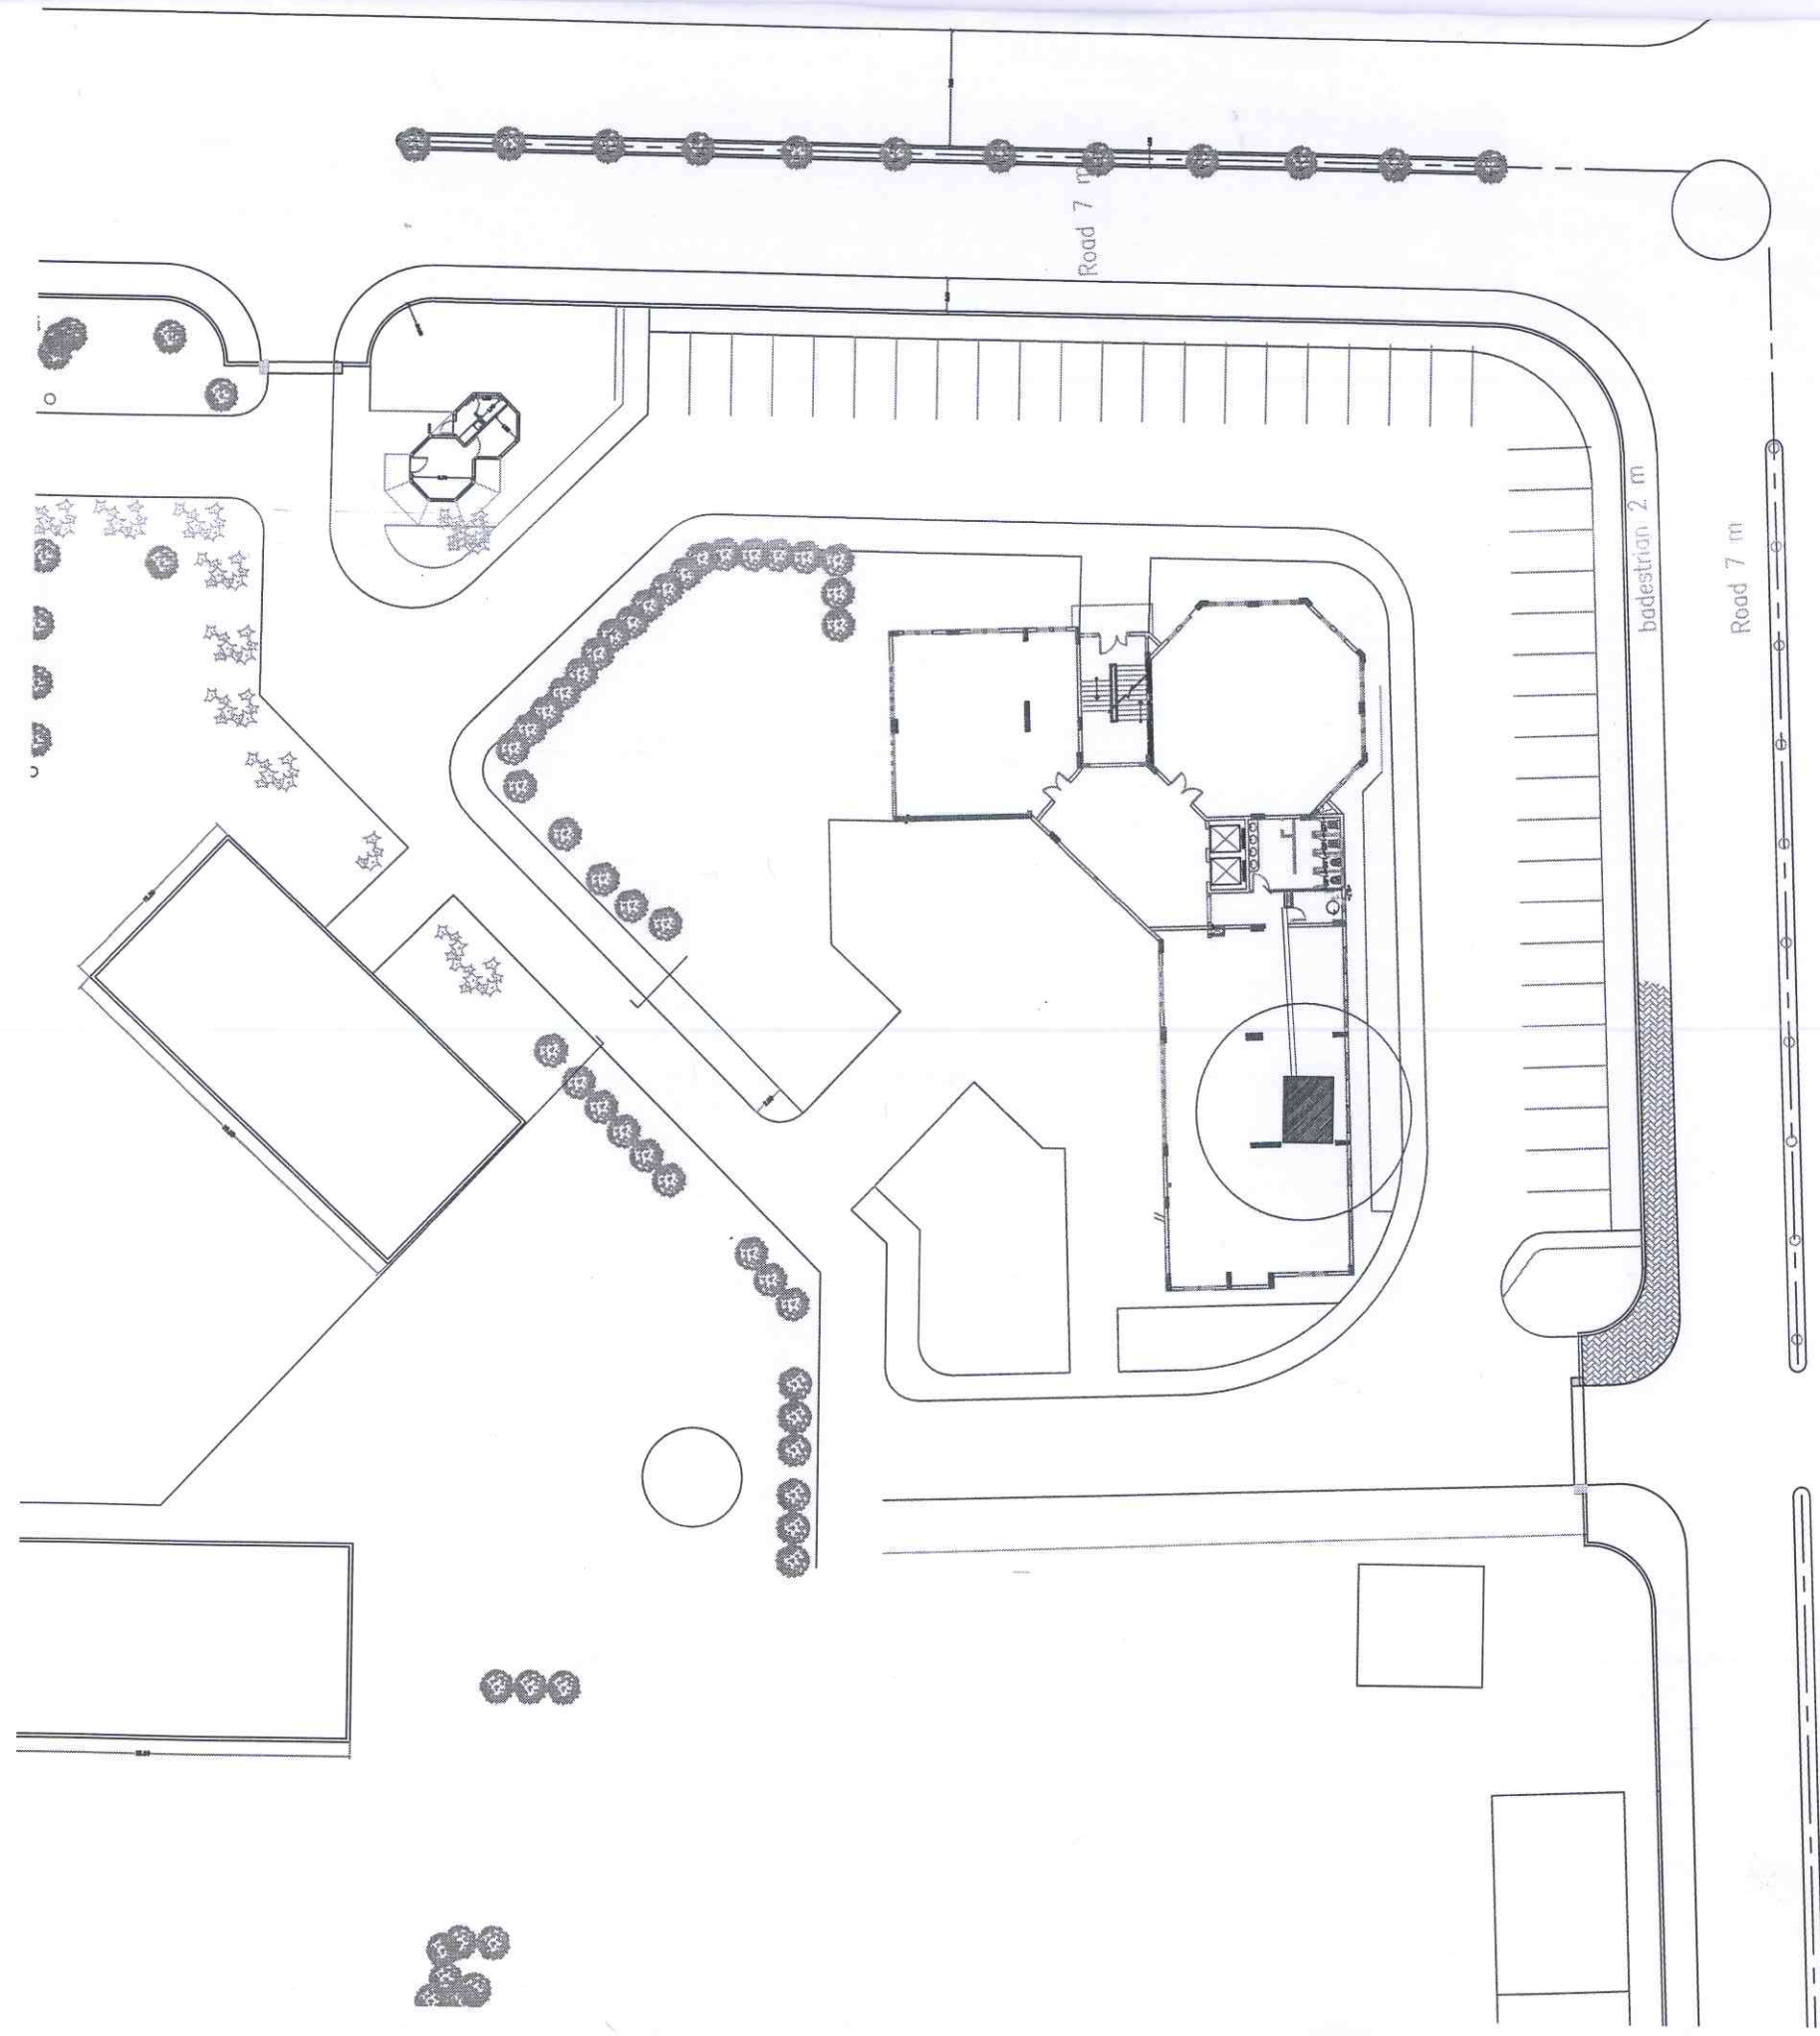

FUNDED BY :



The OPEC Fund for International  
Development - OFID

## NOTES:

- THE CONTRACTOR SHALL SUBMIT THE MANUFACTURES, CATALOGS, DIMENSIONS, DETAILS AND CONNECTIONS FOR ELECTROCHEMICAL WORKS BEFORE STARTING THE WORKS FOR THE ENGINEER'S APPROVAL.
- THE CONTRACTOR SHALL SUBMIT SHOP DRAWINGS FOR ALL WORKS FOR ENGINEER'S APPROVAL.
- ALL THE WORKS TO BE SUPPLIED, EXECUTED AND TESTED AS PER SPECIFICATIONS, CONDITION'S OF CONTRACT, DRAWINGS AND THE ENGINEER'S APPROVAL.

FOR TENDER ONLY

GRAPHIC SCALE 0 1 2 3 4

NO DATE ENG REVISIONS

## CLIENT:



Ministry Of Education

## EMPLOYER:



United Nations Development  
Programme  
Programme of Assistance to the  
Palestinian People  
UNDP/PAPP

## PROJECT TITLE:

Construction of New Small Scale Desalination  
Units for Education Sector in the Gaza Strip

## DRAWING TITLE :

LOT#1 1-Al Shoka School

2-Abassan Elem. Girls School

3-Beni Sohila School

4-Islamic Uni. South Dep.

PREPARED BY	UNDP	SCALE	1:100	DRAWING NO.	D.Jug-2
CHECKED BY	UNDP	APPROVED BY	UNDP	SERIAL NO.	0/00
DRAWN BY	UNDP	DATE	JUN 2018		