



**KINGDOM OF SAUDIA ARABIA
THE SAUDI FUND FOR DEVELOPMENT (SFD)**

PROJECT NAME

Reconstruction and repair works of more than 150 effected houses for non-refugees and Rehabilitation and Furniture for field playgrounds and a culture center

Lot#7

Installation of Stadium lighting for 3 playgrounds in Gaza Strip
(Beit-Hanoun, Al-Dorrah and Khanyounis playgrounds)

DONATED BY

Kingdom of Saudi Arabia through the Saudi Fund for Development (SFD)

EMPLOYER

United Nations Releif and Works Agency (UNRWA)
Through United Nations Development Programme (UNDP/PAPP)



Drawings

PROJECT TITLE:

Reconstruction and repair works of more than 150 effected houses for non-refugees and Rehabilitation and Furniture for field playgrounds and a culture center

Lot :#7 Installation of stadium lighting for 3playgrounds

Electrical Drawings

External Lighting Beit Hanoun

External Lighting Khan Younis


External Lighting Al Dorra



FUNDED BY :
THE KINGDOM OF SAUDI ARABIA
THROUGH THE SAUDI FUND FOR
DEVELOPMENT (SFD)



LEGEND:

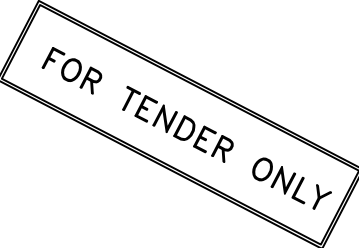

SYM.		NAME	
GRAPHIC SCALE		0 1 2 3 4	
NO	DATE	ENG	REVISIONS
CLIENT:			
EMPLOYER: UNITED NATIONS RELIEF AND WORKS AGENCY (UNRWA) THROUGH UNITED NATIONS DEVELOPMENT PROGRAMME (UNDP/PAPP)			
CONSULTANT:			
PROJECT TITLE: Reconstruction and repair works of more than 150 effected houses for non-refugees and Rehabilitation and Furniture for field playgrounds and a culture center. Lot#7: installation of stadium lighting for 3 playgrounds			
DRAWING TITLE: Electrical Works			
PREPARED BY	SCALE	DRAWING NO.	
CHECKED BY	APPROVED BY	SERIAL NO.	
DRAWN BY	DATE		


No.	Name of Plan
E - 00	Table of content
E - 01	Under ground Power Cables laying in khanyounis play ground
E - 02	Under ground Power Cables laying in Beit Hanoun play ground
E - 03	Under ground Power Cables laying in AL-Dura play ground
E - 04	locations of lighting poles in khanyounis play ground
E - 05	locations of lighting poles in Beit Hanoun play ground
E - 06	locations of lighting poles in Al-Dura play ground
E - 07	system lightening Rod for pools
E - 08	Main panel for lighting pole
E - 09	Main Distribution Board
E - 10	lighting pole panel
E - 11,13	Pole panel details 1
E - 12,14	Pole panel details 2
E - 15	Structure for pillars
E - 16	Details of electrical pillar
E - 17	Earthing system,SDB, lighting & power network in Beit Hanoun paly ground



FUNDED BY :
THE KINGDOM OF SAUDI ARABIA
THROUGH THE SAUDI FUND FOR
DEVELOPMENT (SFD)



LEGEND:

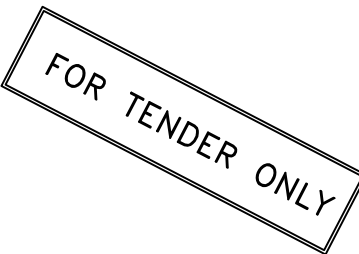

SYM.	NAME
GRAPHIC SCALE 0 1 2 3 4	
NO	DATE
ENG	REVISIONS

CLIENT:

EMPLOYER:

UNITED NATIONS RELIEF AND WORKS AGENCY
(UNRWA) THROUGH UNITED NATIONS
DEVELOPMENT PROGRAMME (UNDP/PAPP)

CONSULTANT:


PROJECT TITLE:

Reconstruction and repair works of more
than 150 effected houses for non-refugees
and Rehabilitation and Furniture for field
playgrounds and a culture center.

Lot#7: installation of stadium lighting for 3
playgrounds

DRAWING TITLE: Table of content

PREPARED BY	SCALE	DRAWING NO.
CHECKED BY	APPROVED BY	E-00
DRAWN BY	DATE	SERIAL NO.

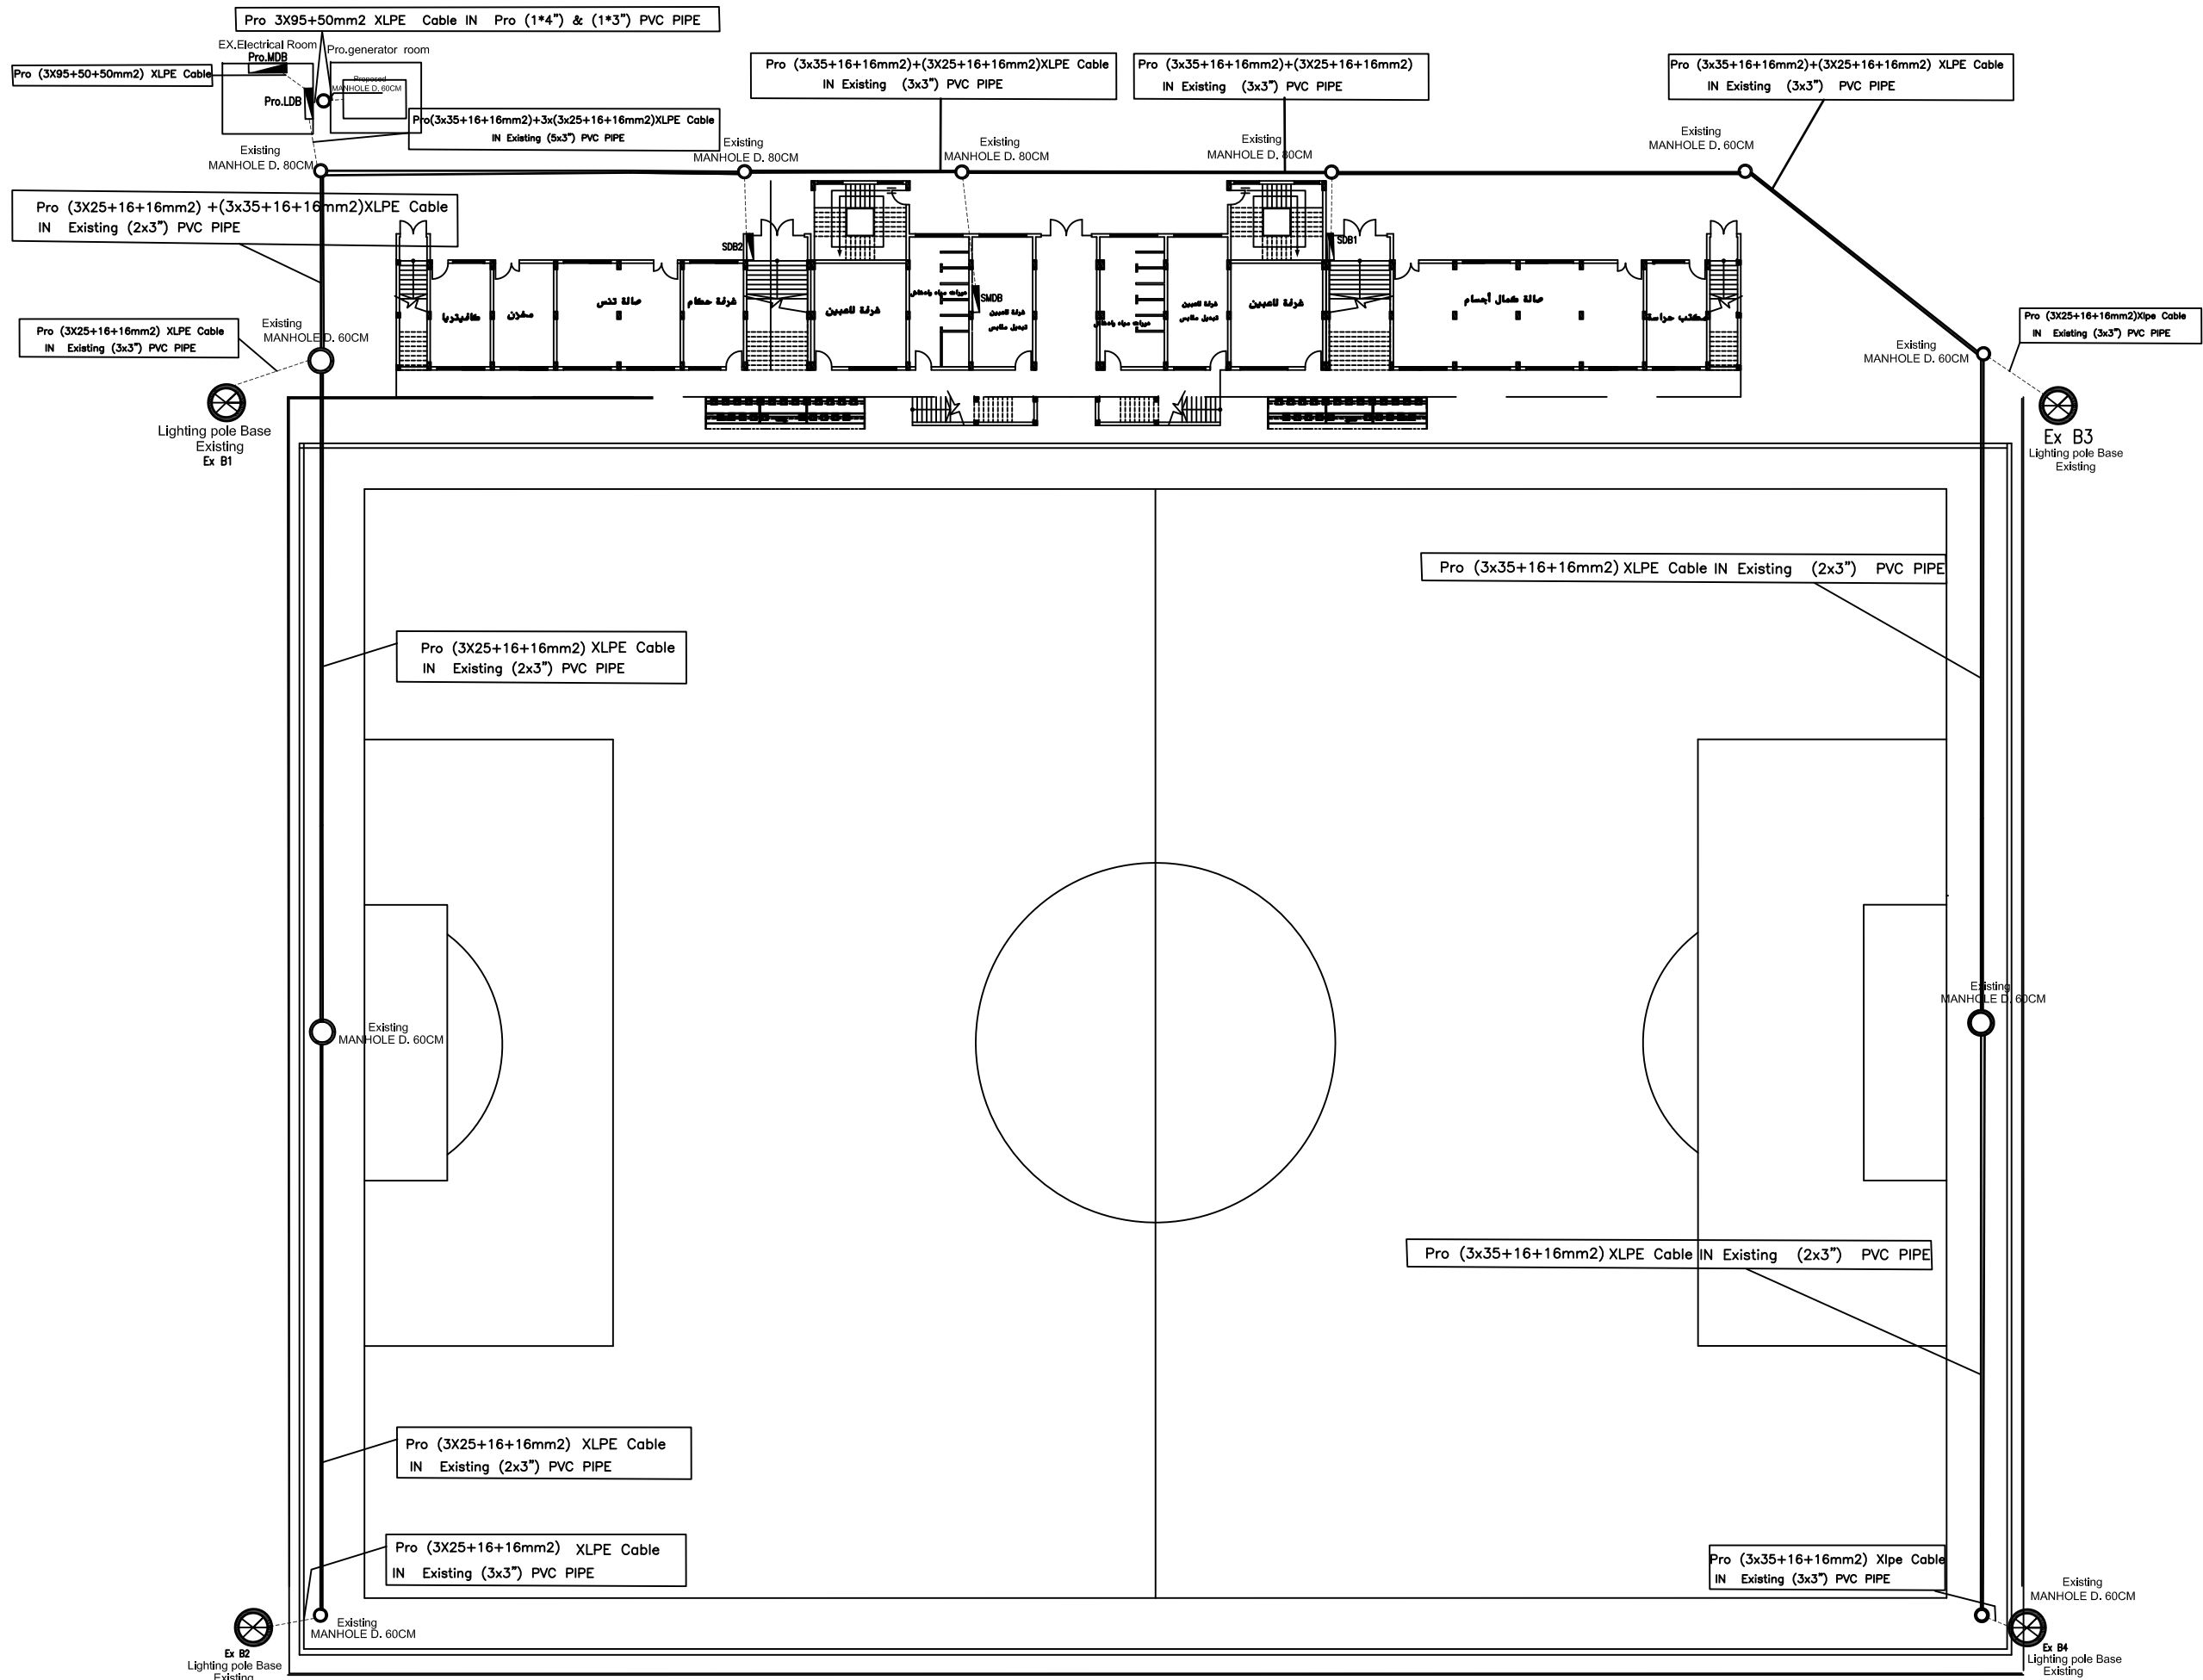


Under ground Power Cables laying in khanyounis play ground



FUNDED BY :
THE KINGDOM OF SAUDI ARABIA
THROUGH THE SAUDI FUND FOR
DEVELOPMENT (SFD)



LEGEND:

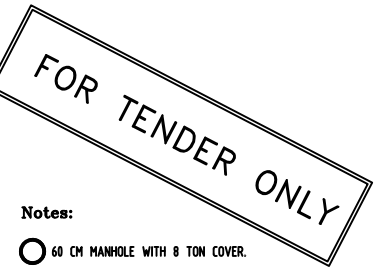

- Notes:
- 60 CM MANHOLE WITH 8 TON COVER.
 - 80 CM MANHOLE WITH 8 TON COVER.
 - Lighting pole



SYM.	NAME
GRAPHIC SCALE	0 1 2 3 4
NO	DATE
ENG	REVISIONS

CLIENT:

EMPLOYER:

UNITED NATIONS RELIEF AND WORKS AGENCY
(UNRWA) THROUGH UNITED NATIONS
DEVELOPMENT PROGRAMME (UNDP/PAPP)

CONSULTANT:


Electrical site layout in khanyounis paly ground

PROJECT TITLE:




Reconstruction and repair works of more
than 150 effected houses for non-refugees
and Rehabilitation and Furniture for field
playgrounds and a culture center.

Lot#7: installation of stadium lighting for 3
playgrounds

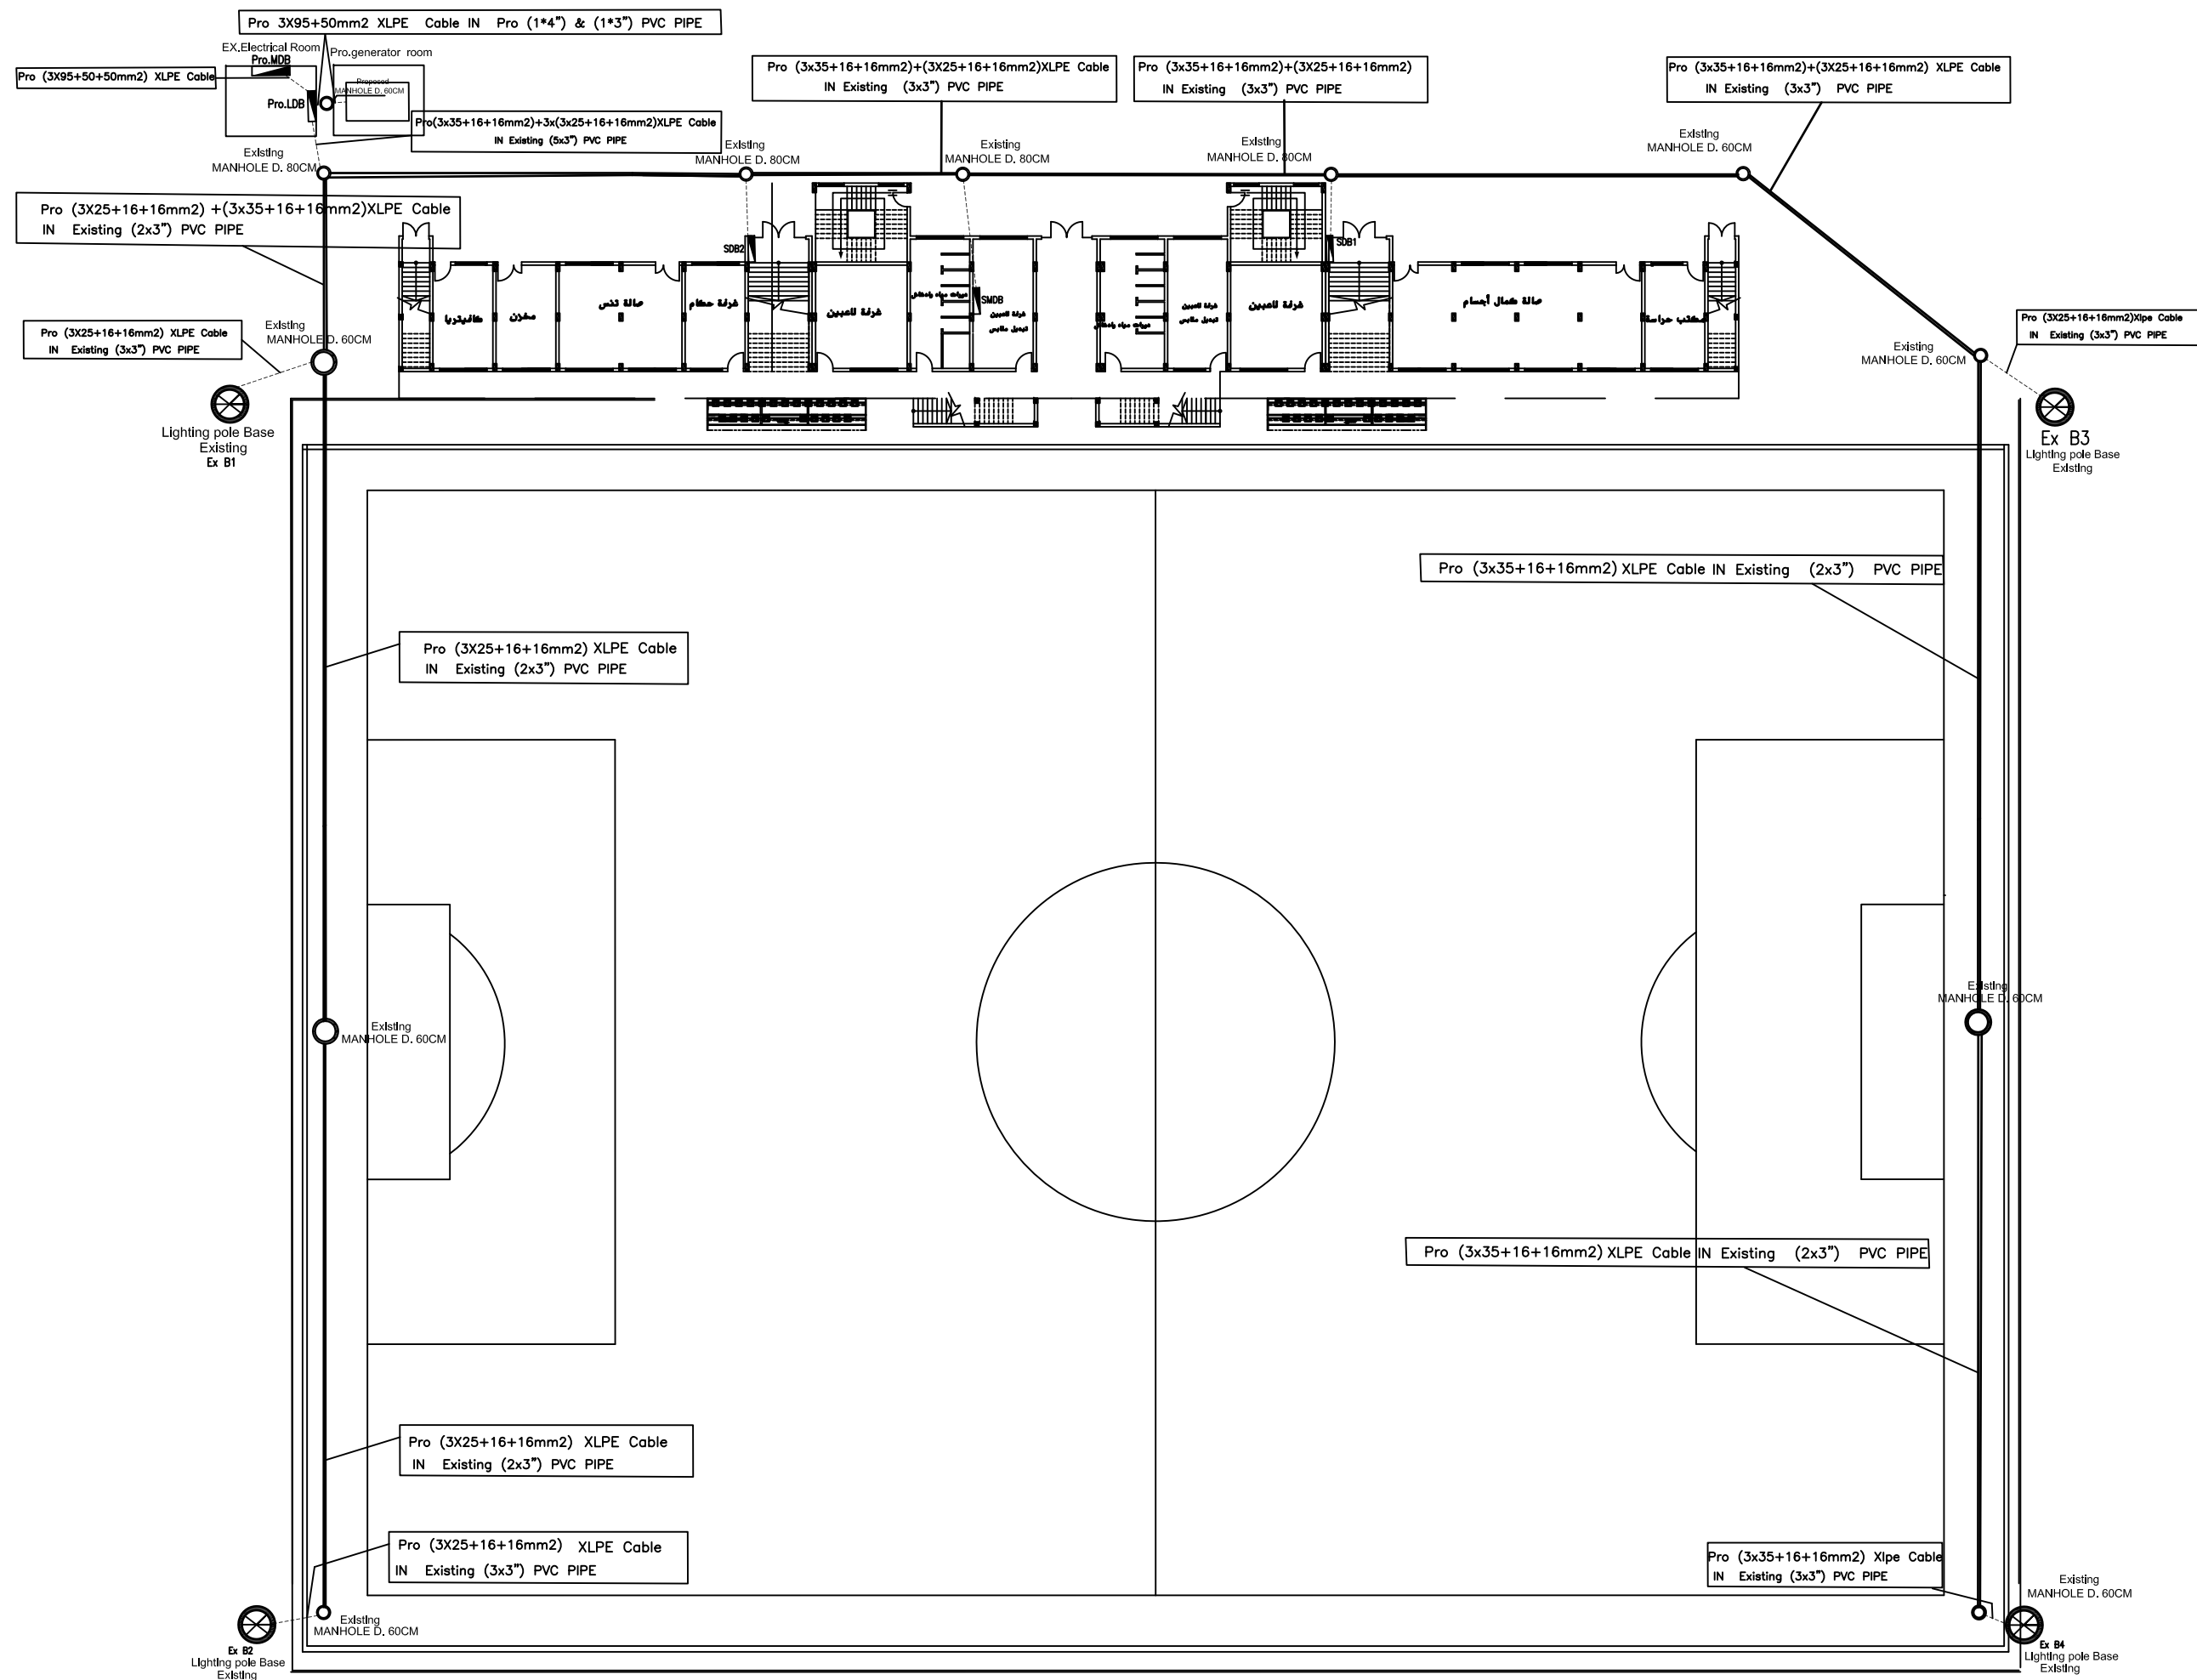DRAWING TITLE :		
Under ground power Cables laying in khanyounis paly ground		
PREPARED BY	SCALE	DRAWING NO.
CHECKED BY	APPROVED BY	E-01
DRAWN BY	DATE	SERIAL NO.



FOR TENDER ONLY

-  60 CM MANHOLE WITH 8 TON COVER.
 80 CM MANHOLE WITH 8 TON COVER.
 Lighting pole



CLIENT:

EMPLOYER:

UNITED NATIONS RELIEF AND WORKS AGENCY
(UNRWA) THROUGH UNITED NATIONS
DEVELOPMENT PROGRAMME (UNDP/PAPP)

CONSULTANT:

Electrical site layout in khanyounis paly ground

PROJECT TITLE:


Reconstruction and repair works of more than 150 effected houses for non-refugees and Rehabilitation and Furniture for field playgrounds and a culture center.

Lot#7: installation of stadium lighting for 3 playgrounds

DRAWING TITLE :
Under ground power Cables laying In khanyounls paly ground

PREPARED BY	SCALE	DRAWING NO. E-01 SERIAL NO.
CHECKED BY	APPROVED BY	
DRAWN BY	DATE	

مدرج قائم

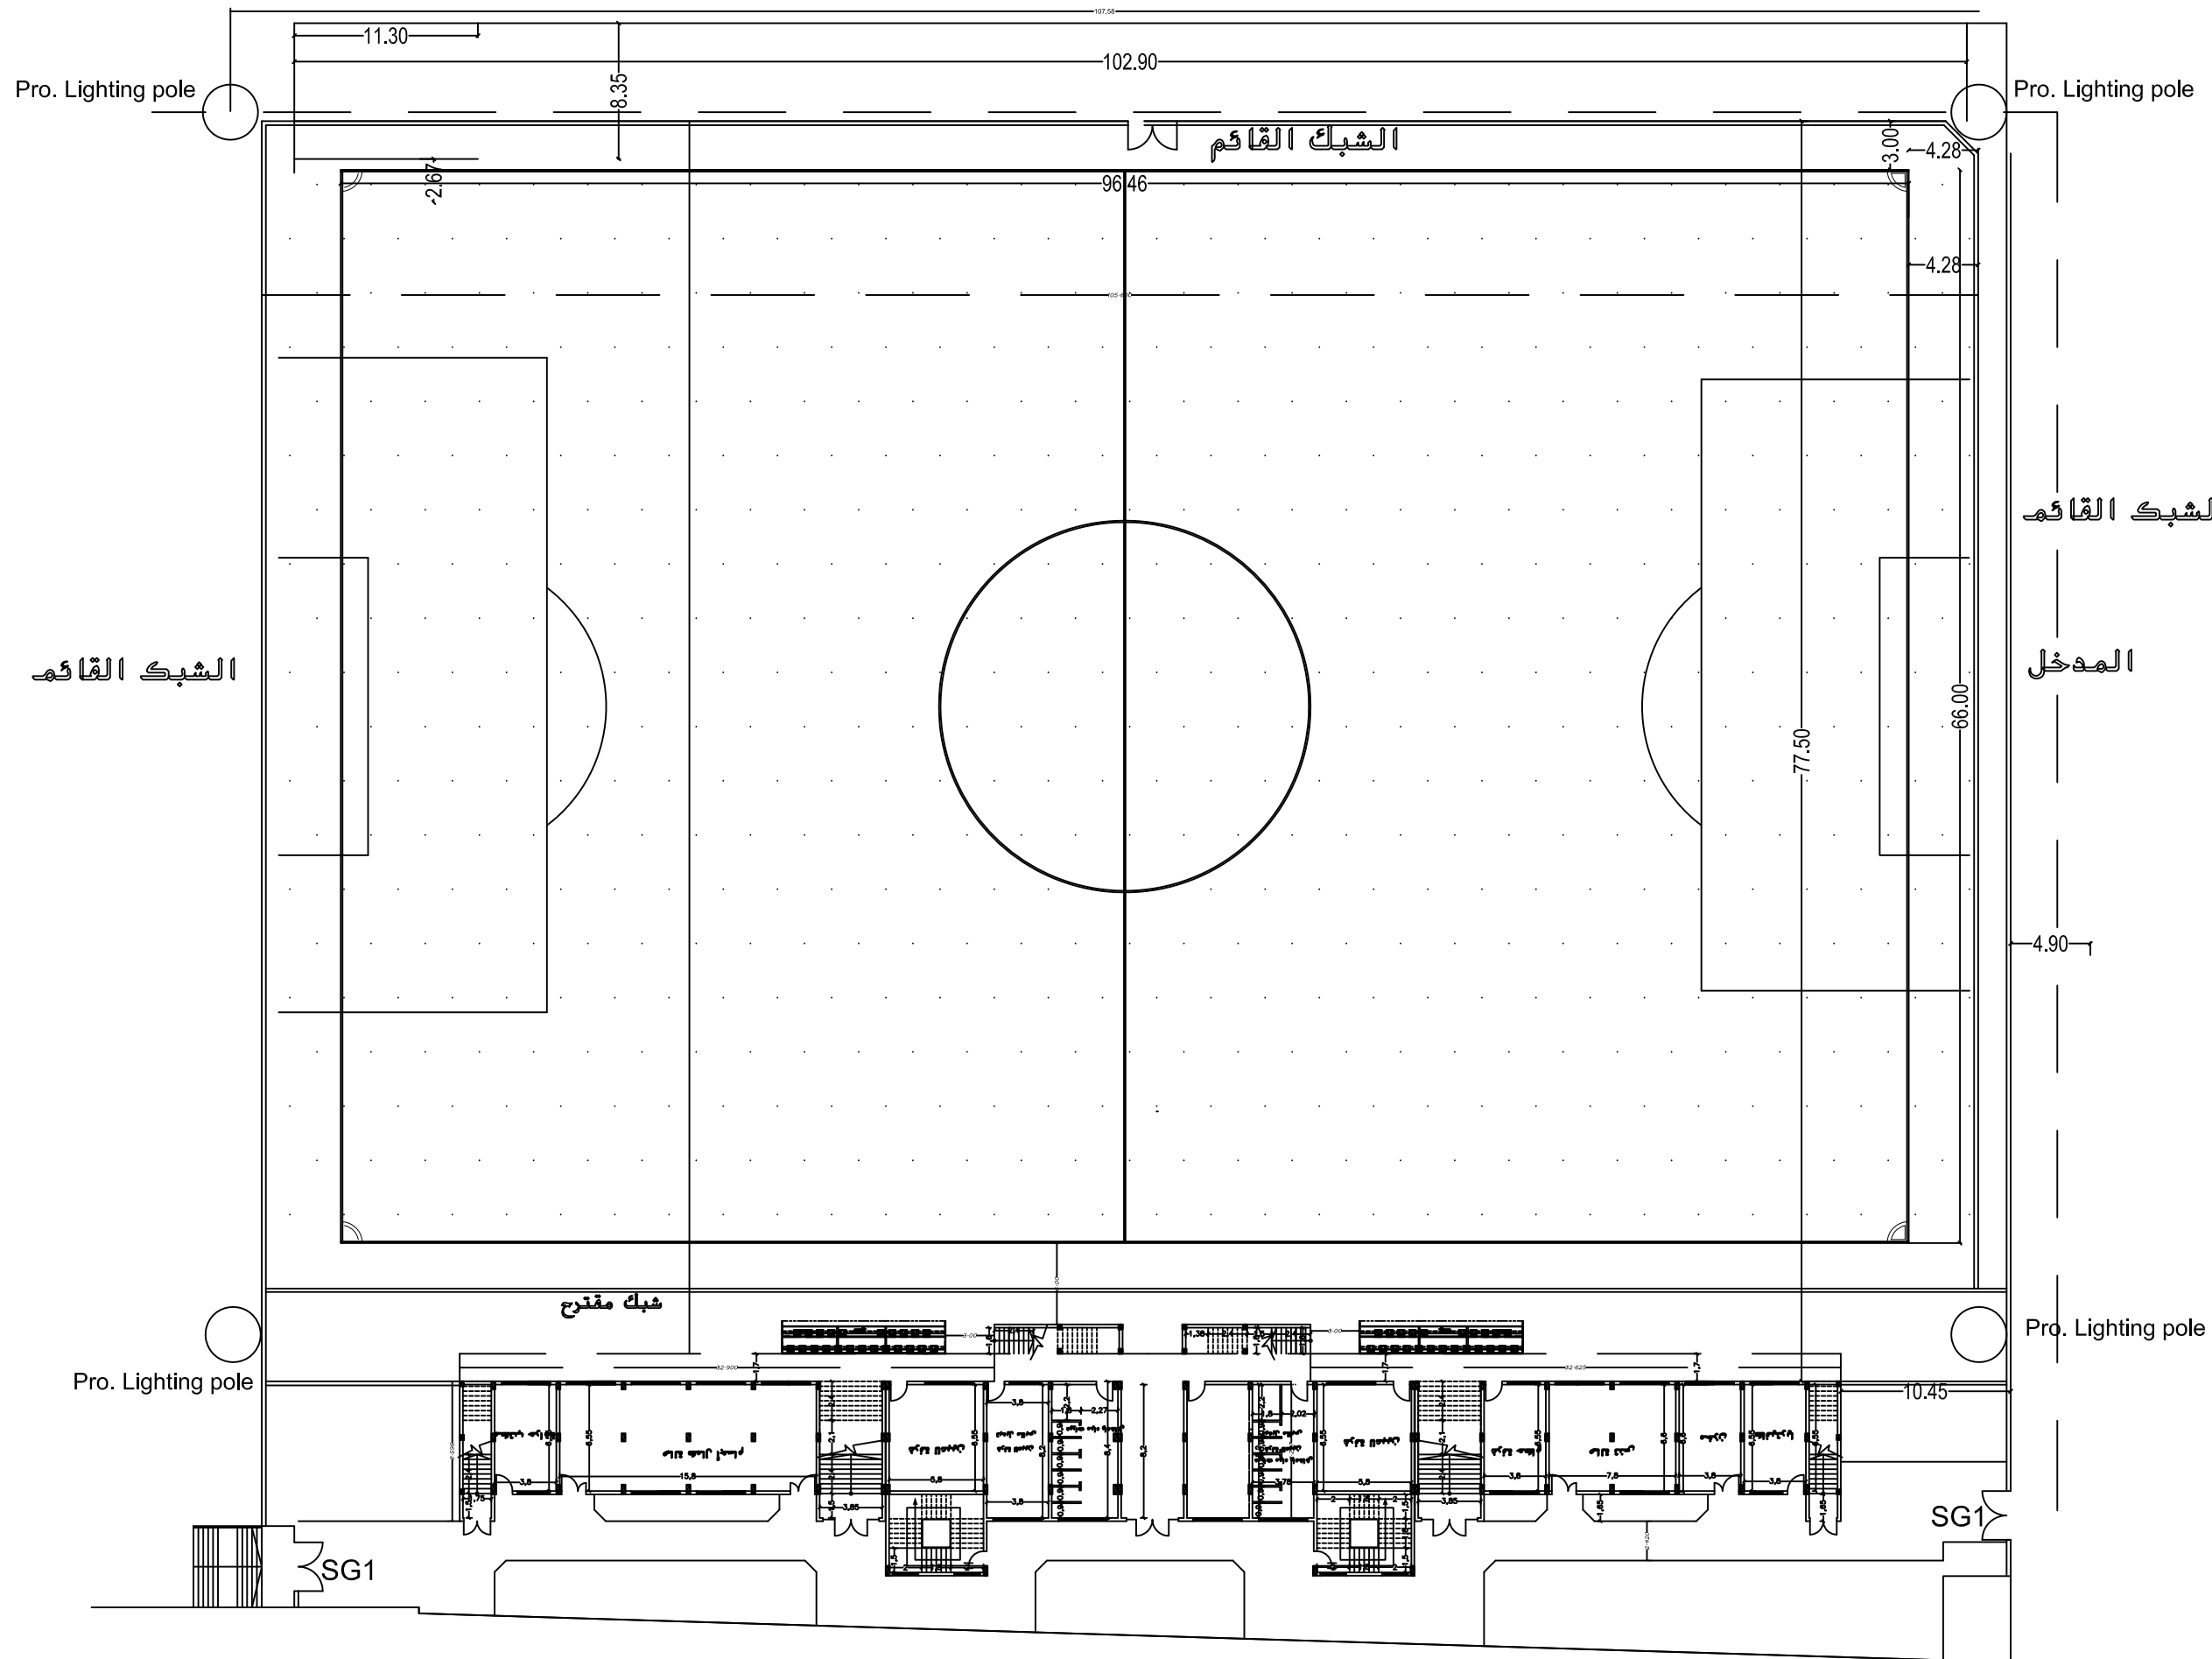

Locations of lighting poles In khanyounis play ground



FUNDED BY :
THE KINGDOM OF SAUDI ARABIA
THROUGH THE SAUDI FUND FOR
DEVELOPMENT (SFD)



LEGEND:

FOR TENDER ONLY



SYM.	NAME
GRAPHIC SCALE 0 1 2 3 4	
NO	DATE
ENG	REVISIONS


CLIENT:

EMPLOYER:
UNITED NATIONS RELIEF AND WORKS AGENCY
(UNHCR) THROUGH UNITED NATIONS
DEVELOPMENT PROGRAMME (UNDP/PAPP)

CONSULTANT:

PROJECT TITLE:
Reconstruction and repair works of more
than 150 effected houses for non-refugees
and Rehabilitation and Furniture for field
playgrounds and a culture center.
Lot#7: installation of stadium lighting for 3
playgrounds

DRAWING TITLE : Locations of lighting poles In khanyounis play ground		
PREPARED BY	SCALE	DRAWING NO.
CHECKED BY	APPROVED BY	E-04
DRAWN BY	DATE	SERIAL NO.

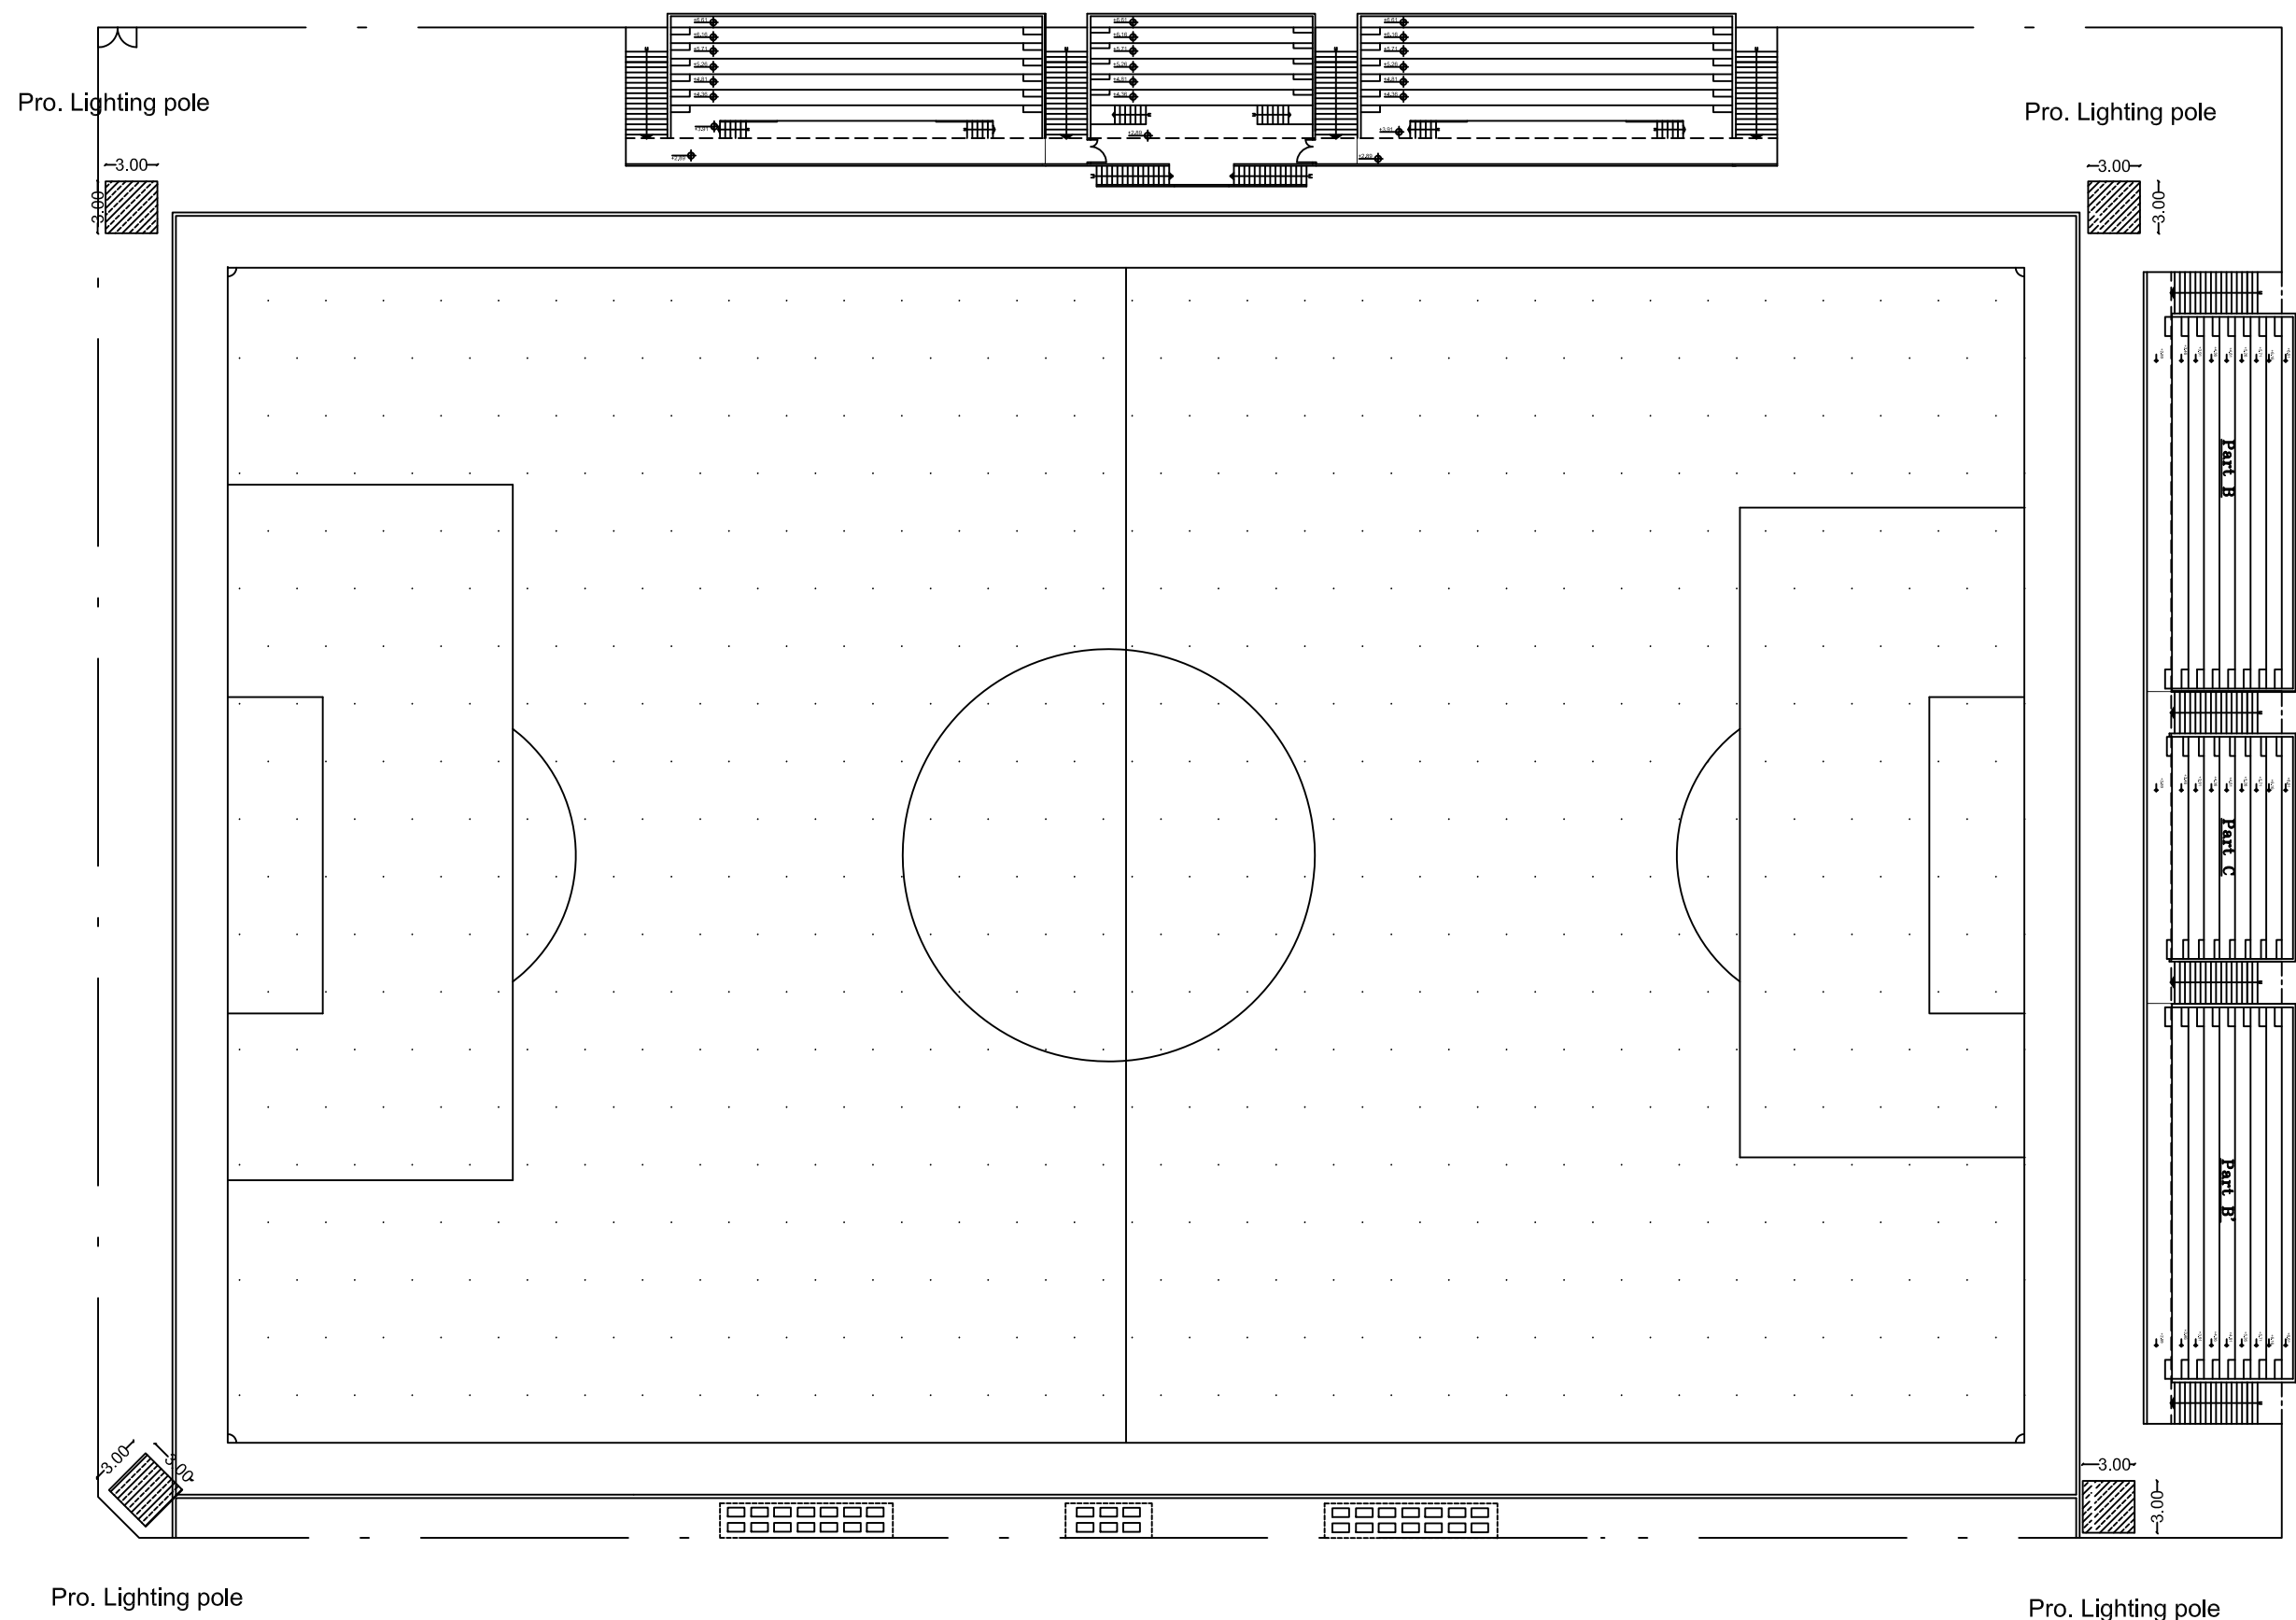

Locations of lighting poles In Beit Hanoun play ground




FUNDED BY :
THE KINGDOM OF SAUDI ARABIA
THROUGH THE SAUDI FUND FOR
DEVELOPMENT (SFD)



LEGEND:

FOR TENDER ONLY



SYM.		NAME	
GRAPHIC SCALE			
			
NO	DATE	ENG	REVISIONS

CLIENT:

EMPLOYER:

UNITED NATIONS RELIEF AND WORKS AGENCY
(UNRWA) THROUGH UNITED NATIONS
DEVELOPMENT PROGRAMME (UNDP/PAPP)

CONSULTANT:

PROJECT TITLE:


Reconstruction and repair works of more
than 150 effected houses for non-refugees
and Rehabilitation and Furniture for field
playgrounds and a culture center.

Lot#7: installation of stadium lighting for 3
playgrounds

DRAWING TITLE :

Locations of lighting poles In Beit Hanoun play ground

PREPARED BY	SCALE	DRAWING NO.
CHECKED BY	APPROVED BY	E-05
DRAWN BY	DATE	SERIAL NO.

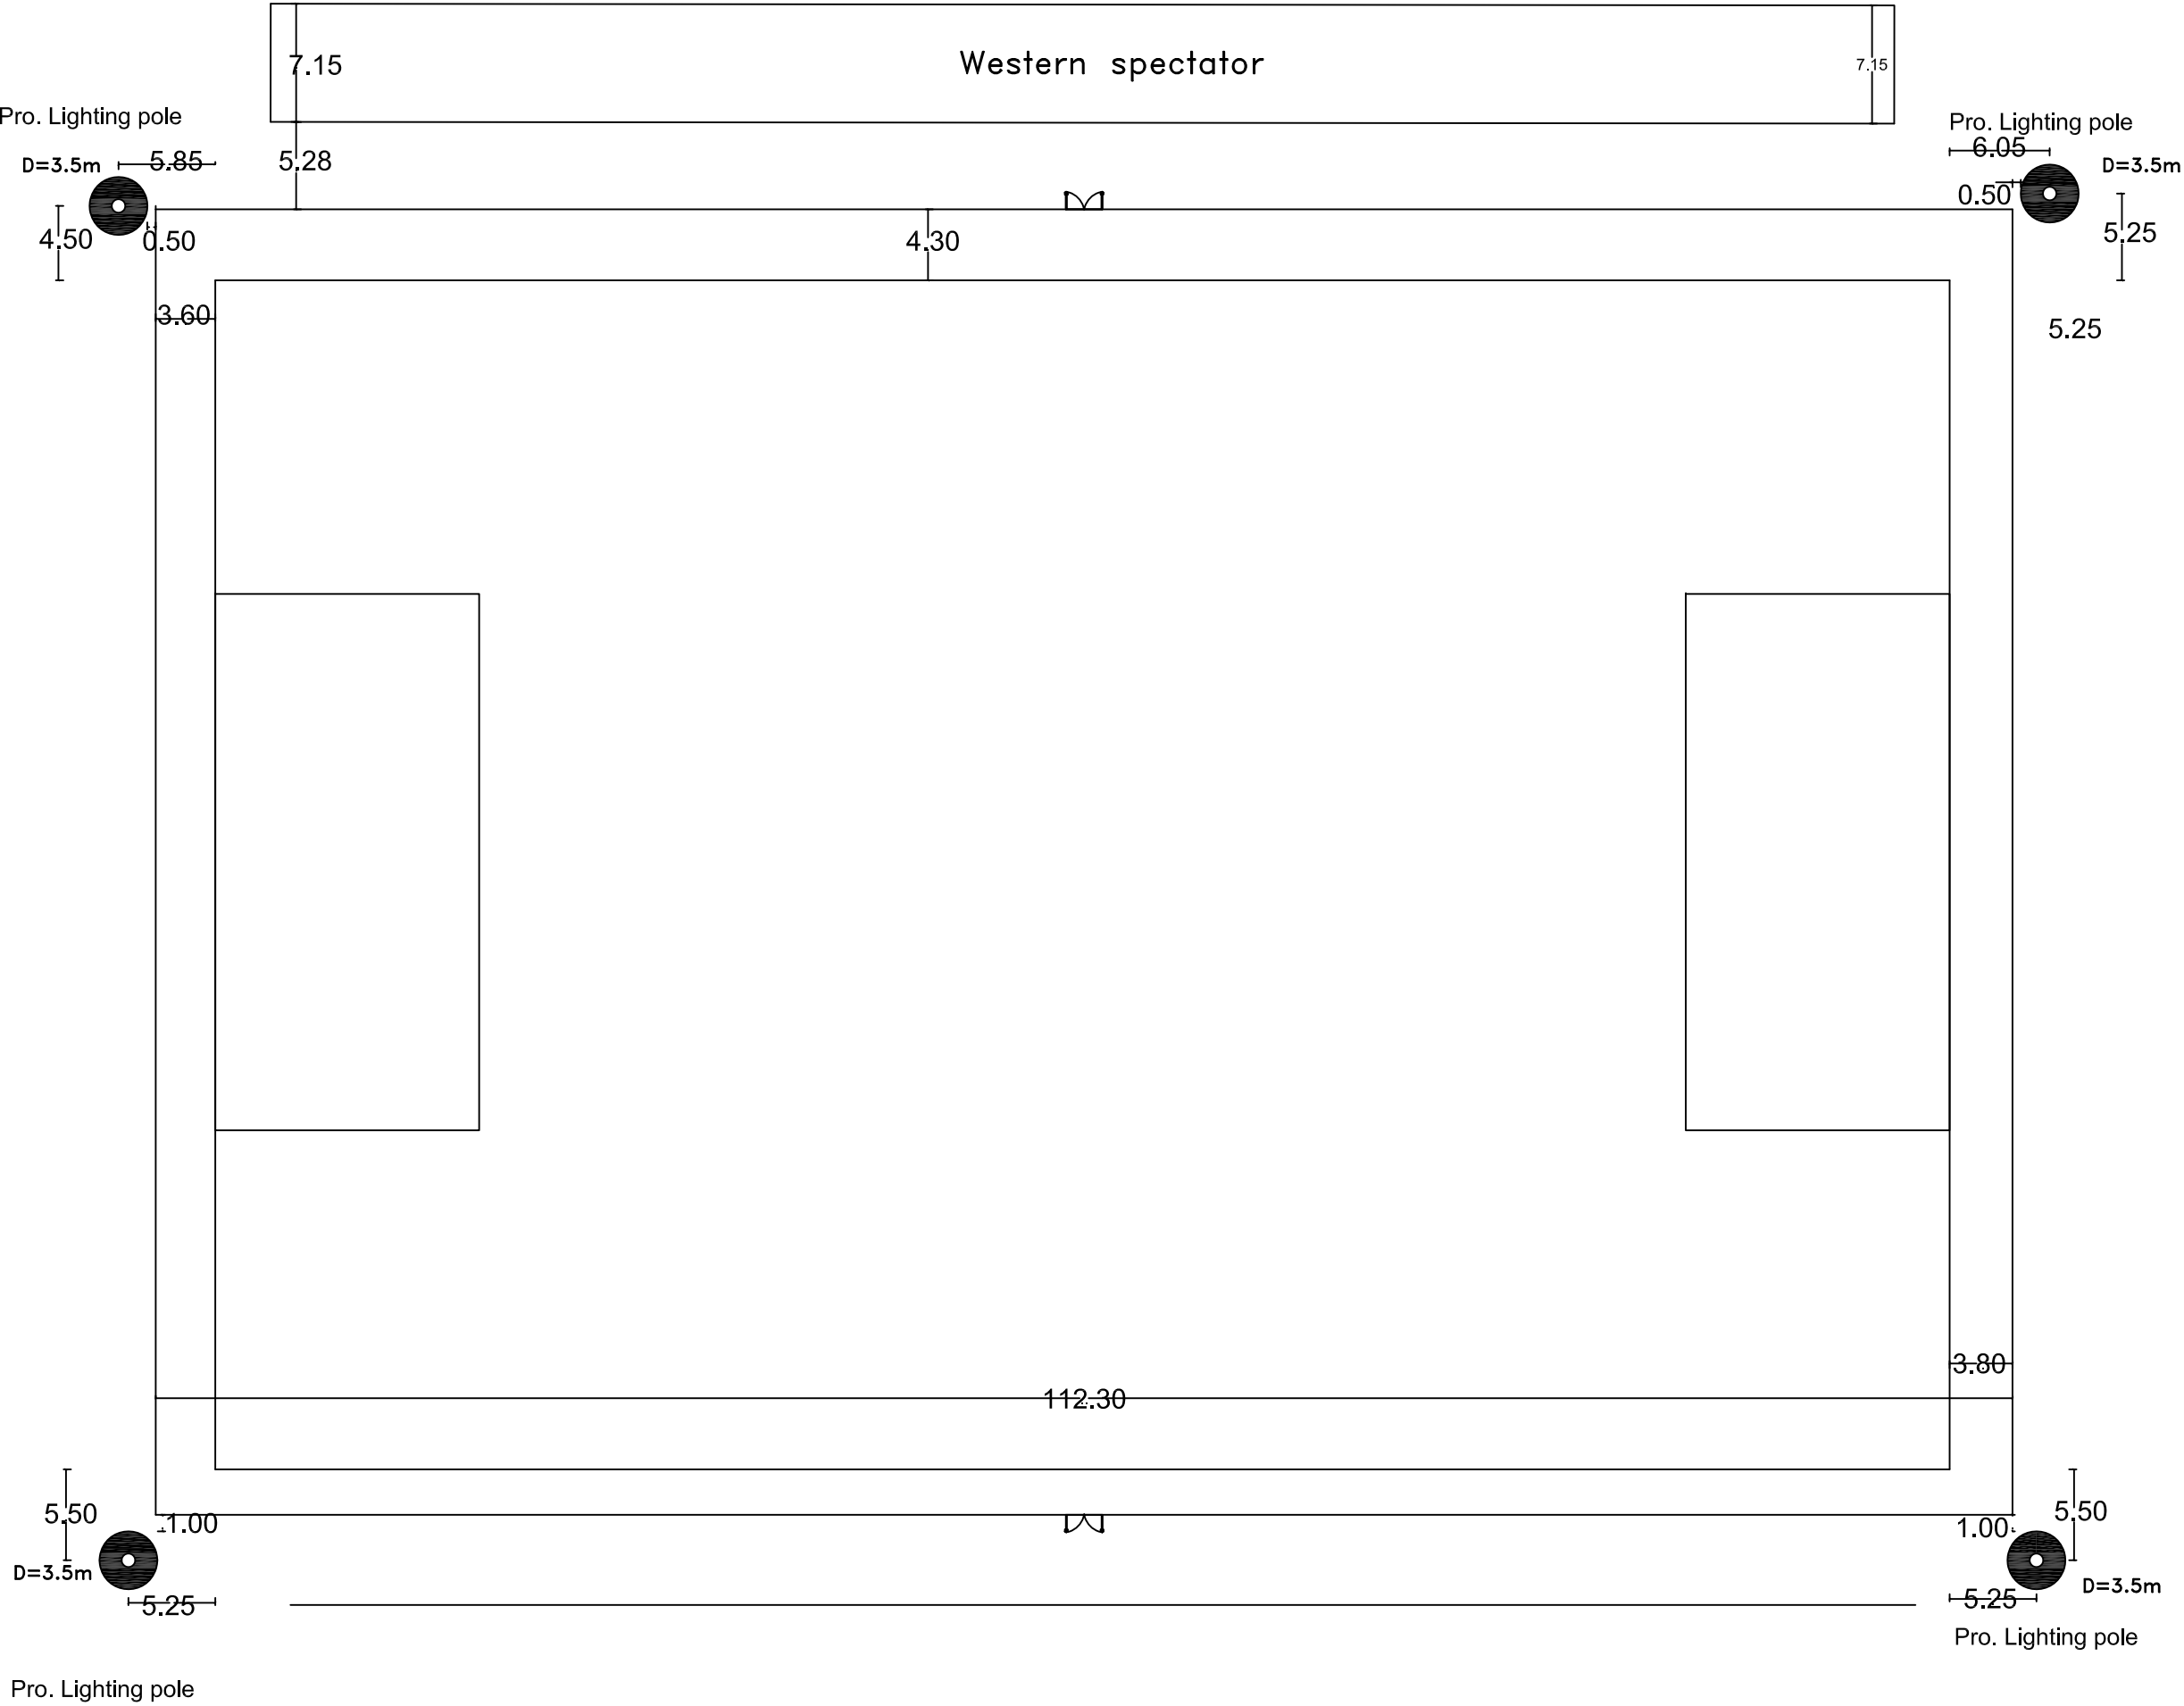


FUNDED BY :
THE KINGDOM OF SAUDI ARABIA
THROUGH THE SAUDI FUND FOR
DEVELOPMENT (SFD)



LEGEND:

FOR TENDER ONLY



SYM.		NAME	
GRAPHIC SCALE			
NO	DATE	ENG	REVISIONS

CLIENT:

EMPLOYER:

UNITED NATIONS RELIEF AND WORKS AGENCY
(UNRWA) THROUGH UNITED NATIONS
DEVELOPMENT PROGRAMME (UNDP/PAPP)


CONSULTANT:

PROJECT TITLE:

Reconstruction and repair works of more
than 150 effected houses for non-refugees
and Rehabilitation and Furniture for field
playgrounds and a culture center.

Lot#7: installation of stadium lighting for 3
playgrounds

DRAWING TITLE :			
Locations of lighting poles In AL-Dura play ground			
PREPARED BY	SCALE	DRAWING NO.	
CHECKED BY	APPROVED BY	E-06	
DRAWN BY	DATE	SERIAL NO.	

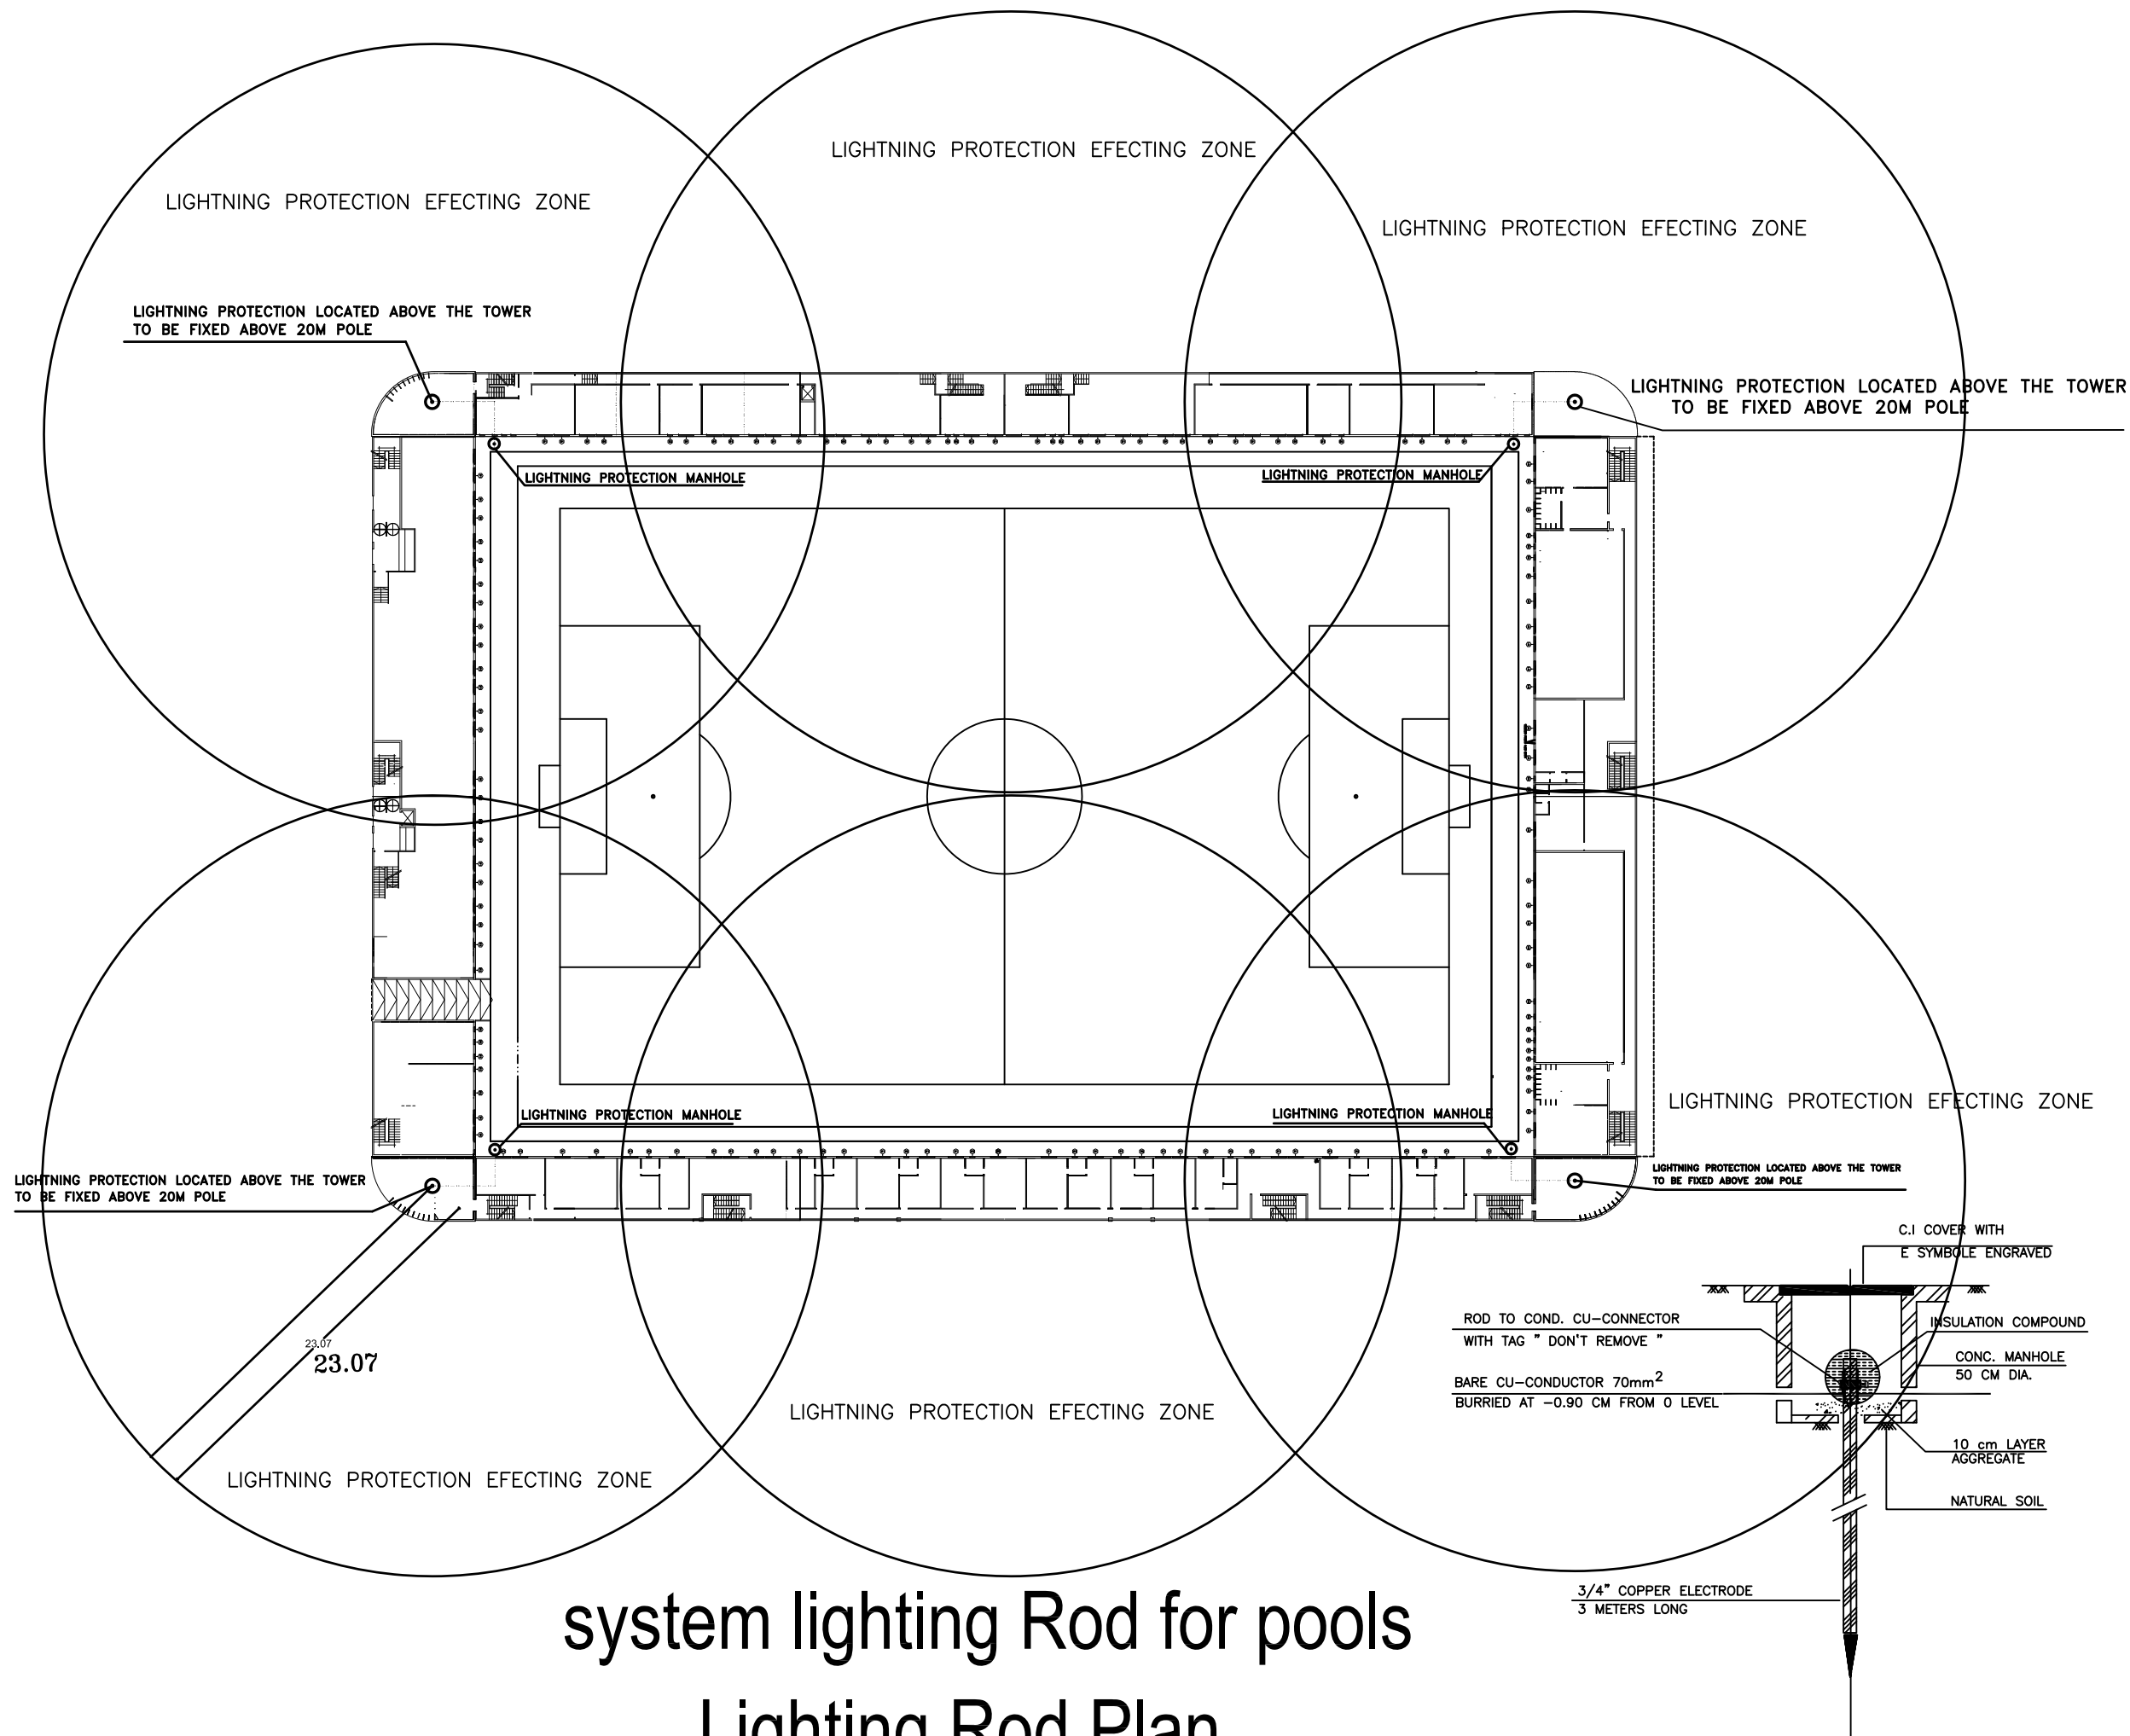

system lighting Rod for pools

Lighting Rod Plan



FUNDED BY :
THE KINGDOM OF SAUDI ARABIA
THROUGH THE SAUDI FUND FOR
DEVELOPMENT (SFD)



LEGEND:

FOR TENDER ONLY



SYM.	NAME
GRAPHIC SCALE 0 1 2 3 4	
NO	DATE
ENG	REVISIONS

CLIENT:

EMPLOYER:

UNITED NATIONS RELIEF AND WORKS AGENCY
(UNRWA) THROUGH UNITED NATIONS
DEVELOPMENT PROGRAMME (UNDP/PAPP)


CONSULTANT:

PROJECT TITLE:

Reconstruction and repair works of more
than 150 effected houses for non-refugees
and Rehabilitation and Furniture for field
playgrounds and a culture center.

Lot#7: installation of stadium lighting for 3
playgrounds

DRAWING TITLE: system lightening Rod for pools		
PREPARED BY	SCALE	DRAWING NO.
CHECKED BY	APPROVED BY	E-07
DRAWN BY	DATE	SERIAL NO.

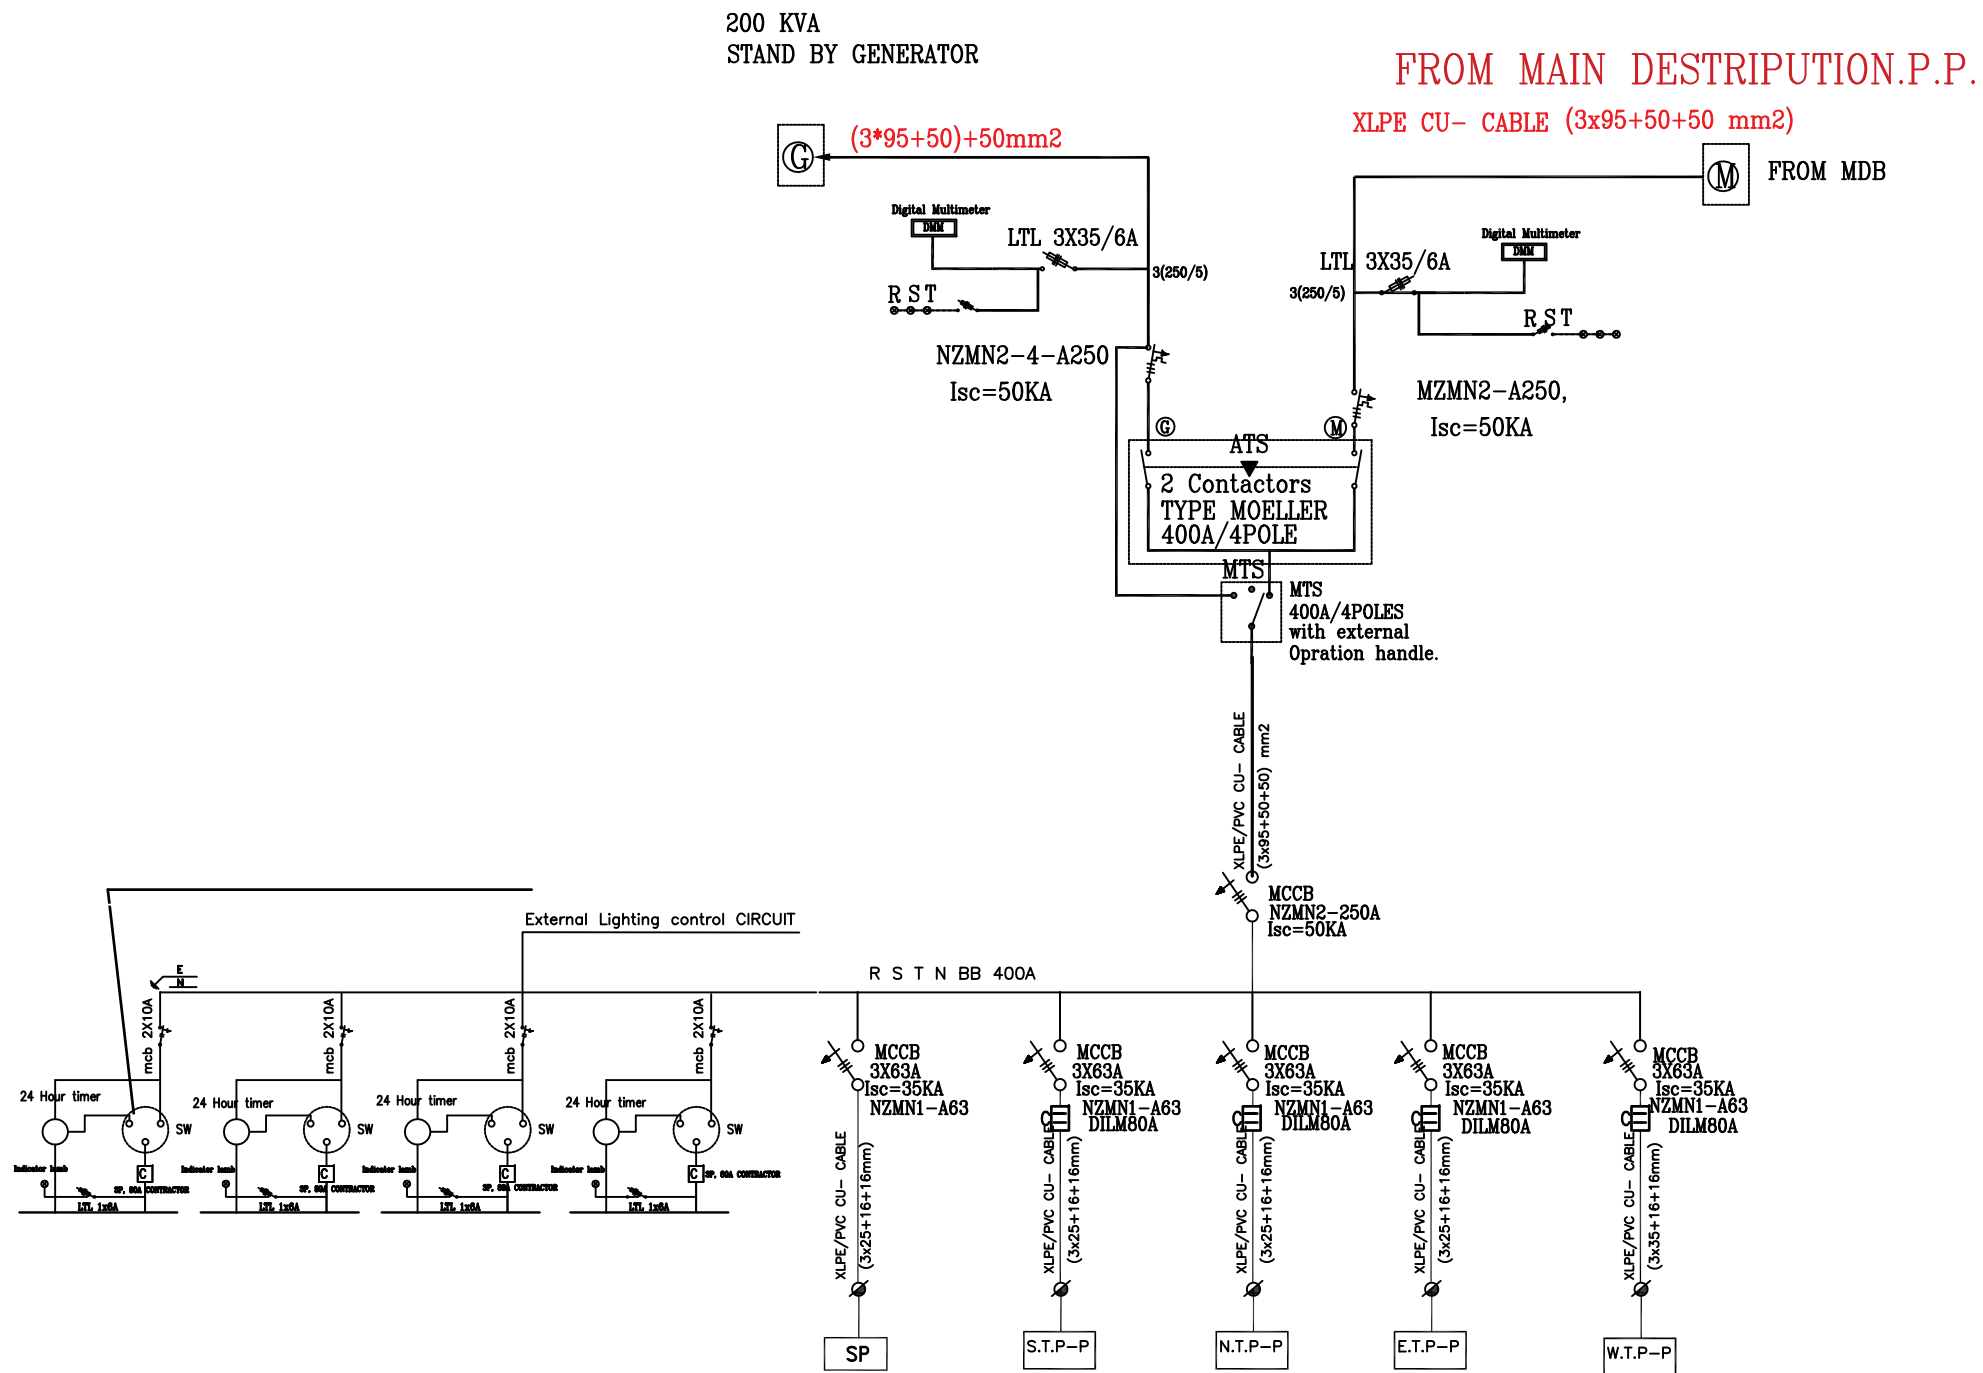

STADIUM LIGHTING PANEL



FUNDED BY :
THE KINGDOM OF SAUDI ARABIA
THROUGH THE SAUDI FUND FOR
DEVELOPMENT (SFD)



LEGEND:

FOR TENDER ONLY



SYM.	NAME
GRAPHIC SCALE 0 1 2 3 4	
NO	DATE
ENG	REVISIONS

CLIENT:

EMPLOYER:
UNITED NATIONS RELIEF AND WORKS AGENCY
(UNHCR) THROUGH UNITED NATIONS
DEVELOPMENT PROGRAMME (UNDP/PAPP)



CONSULTANT:

PROJECT TITLE:
Reconstruction and repair works of more
than 150 effected houses for non-refugees
and Rehabilitation and Furniture for field
playgrounds and a culture center.

Lot#7: installation of stadium lighting for 3
playgrounds

DRAWING TITLE: Main panel for lighting pole		
PREPARED BY	SCALE	DRAWING NO.
CHECKED BY	APPROVED BY	E-08
DRAWN BY	DATE	SERIAL NO.

مفتاح التشغيل اليدوي في حال عطل الفوتوسيل يتم تشغيله
من غرفة التحكم المركزية في البرج الجنوبي الغربي

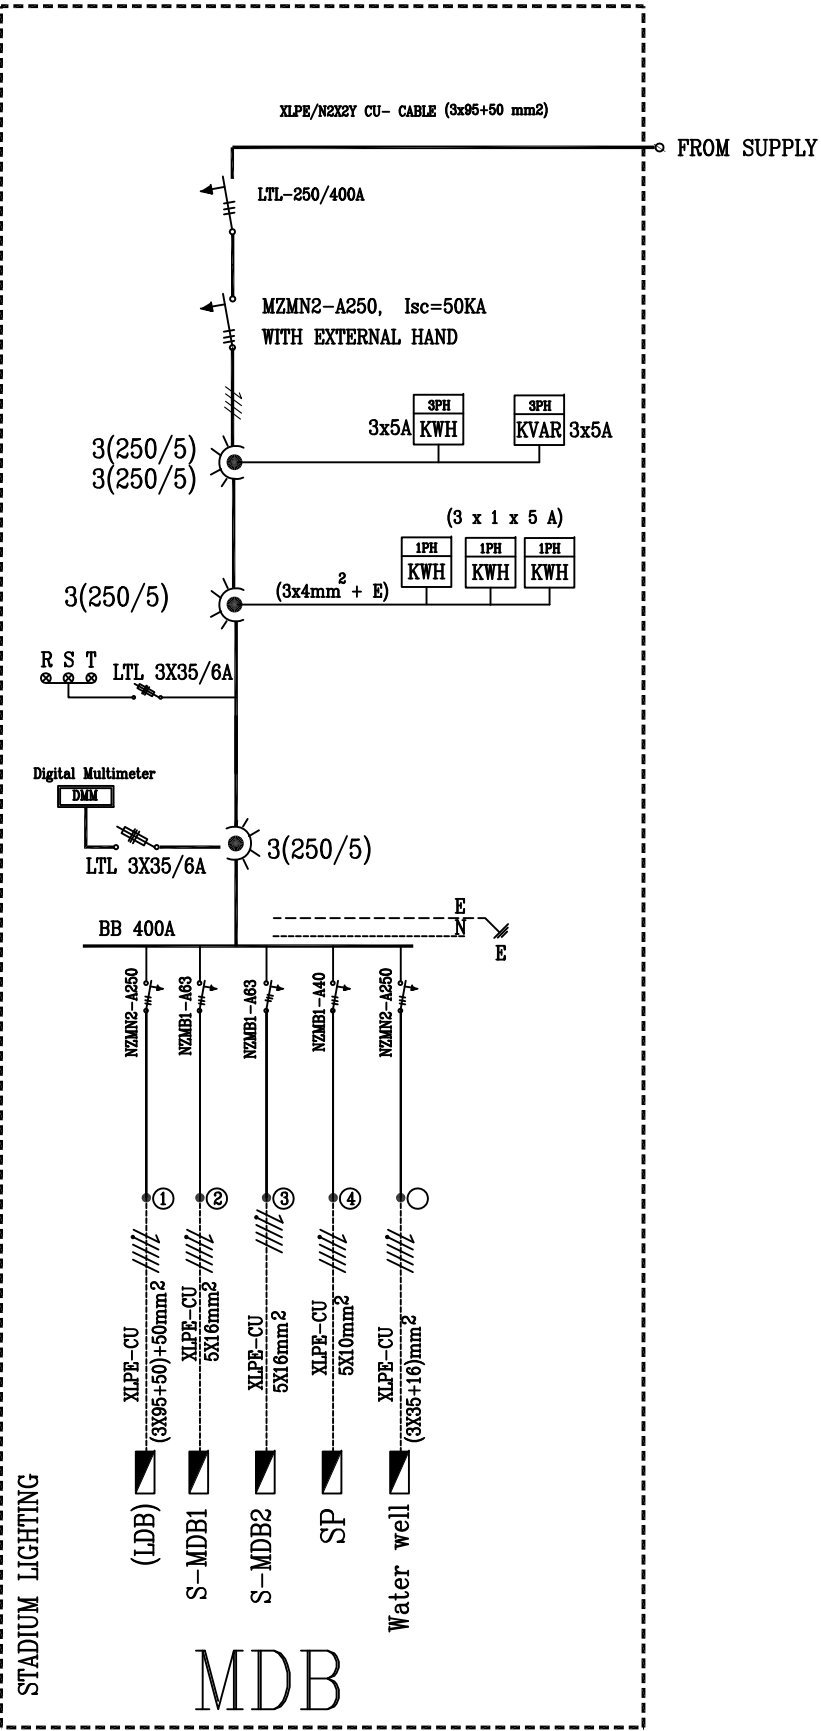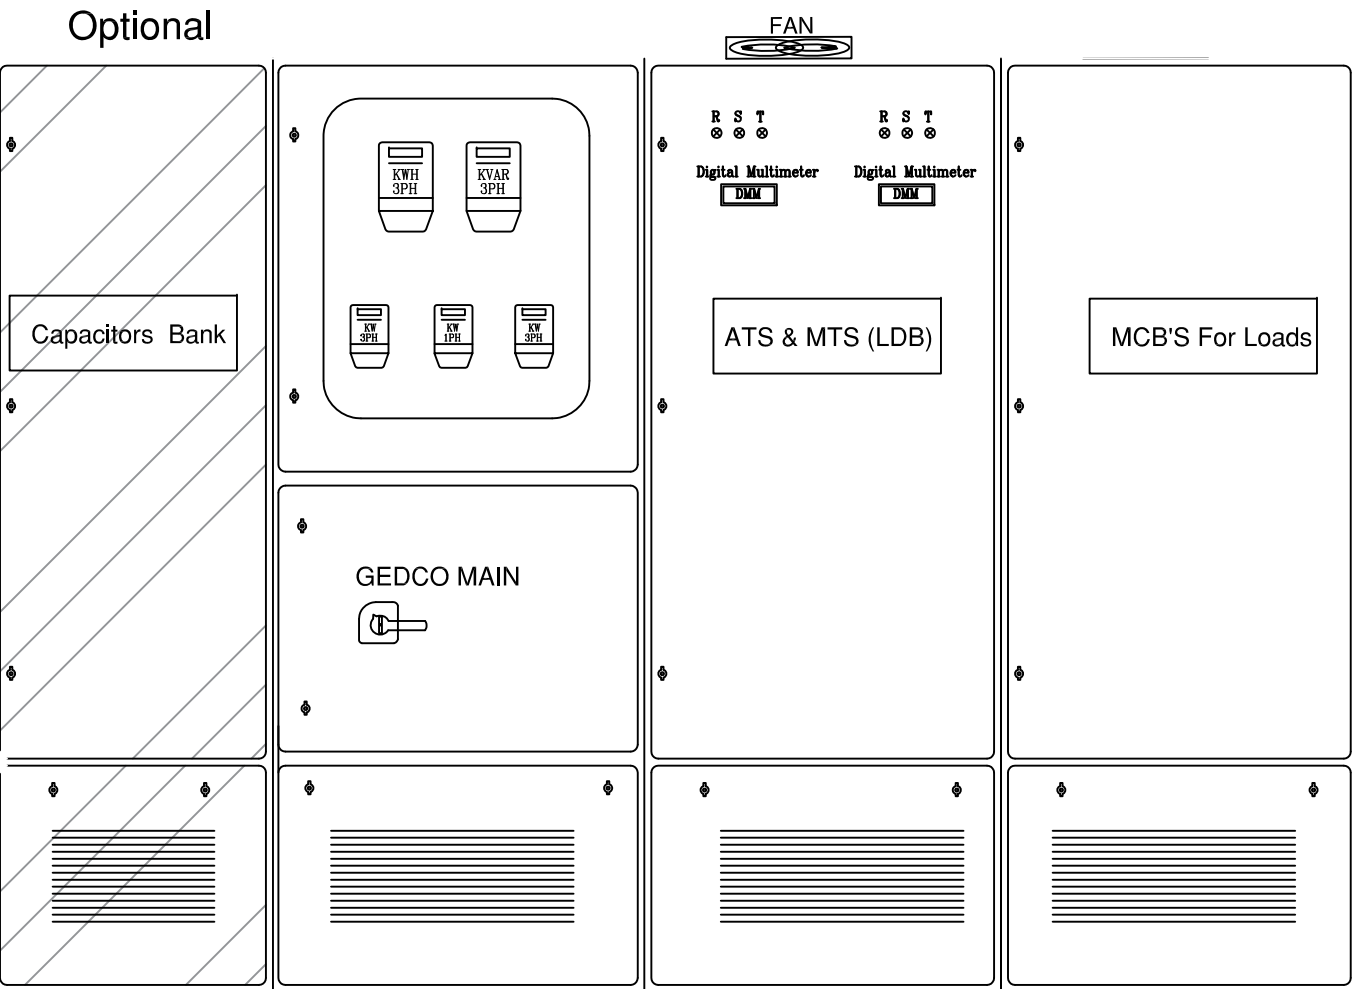

MDB SINGLE LINE DIAGRAM

لوحة الكهرباء الرئيسية لاناارة الملعب تتغذي من اللوحة الرئيسية تقع في غرفة الكهرباء

MDB for (Beit Hanoun & khanyounis) paly grouds.



FUNDED BY :
THE KINGDOM OF SAUDI ARABIA
THROUGH THE SAUDI FUND FOR
DEVELOPMENT (SFD)



LEGEND:

FOR TENDER ONLY



SYM.		NAME	
GRAPHIC SCALE			
0 1 2 3 4			
NO	DATE	ENG	REVISIONS

CLIENT:

EMPLOYER:

UNITED NATIONS RELIEF AND WORKS AGENCY
(UNRWA) THROUGH UNITED NATIONS
DEVELOPMENT PROGRAMME (UNDP/PAPP)

CONSULTANT:

PROJECT TITLE:

Reconstruction and repair works of more than 150 effected houses for non-refugees and Rehabilitation and Furniture for field playgrounds and a culture center.


Lot#7: installation of stadium lighting for 3 playgrounds

DRAWING TITLE :

Main Distribution Borad

PREPARED BY	SCALE	DRAWING NO.
CHECKED BY	APPROVED BY	E-00
DRAWN BY	DATE	SERIAL NO.

FROM EXTERNAL LIGHTING.P (LDB).

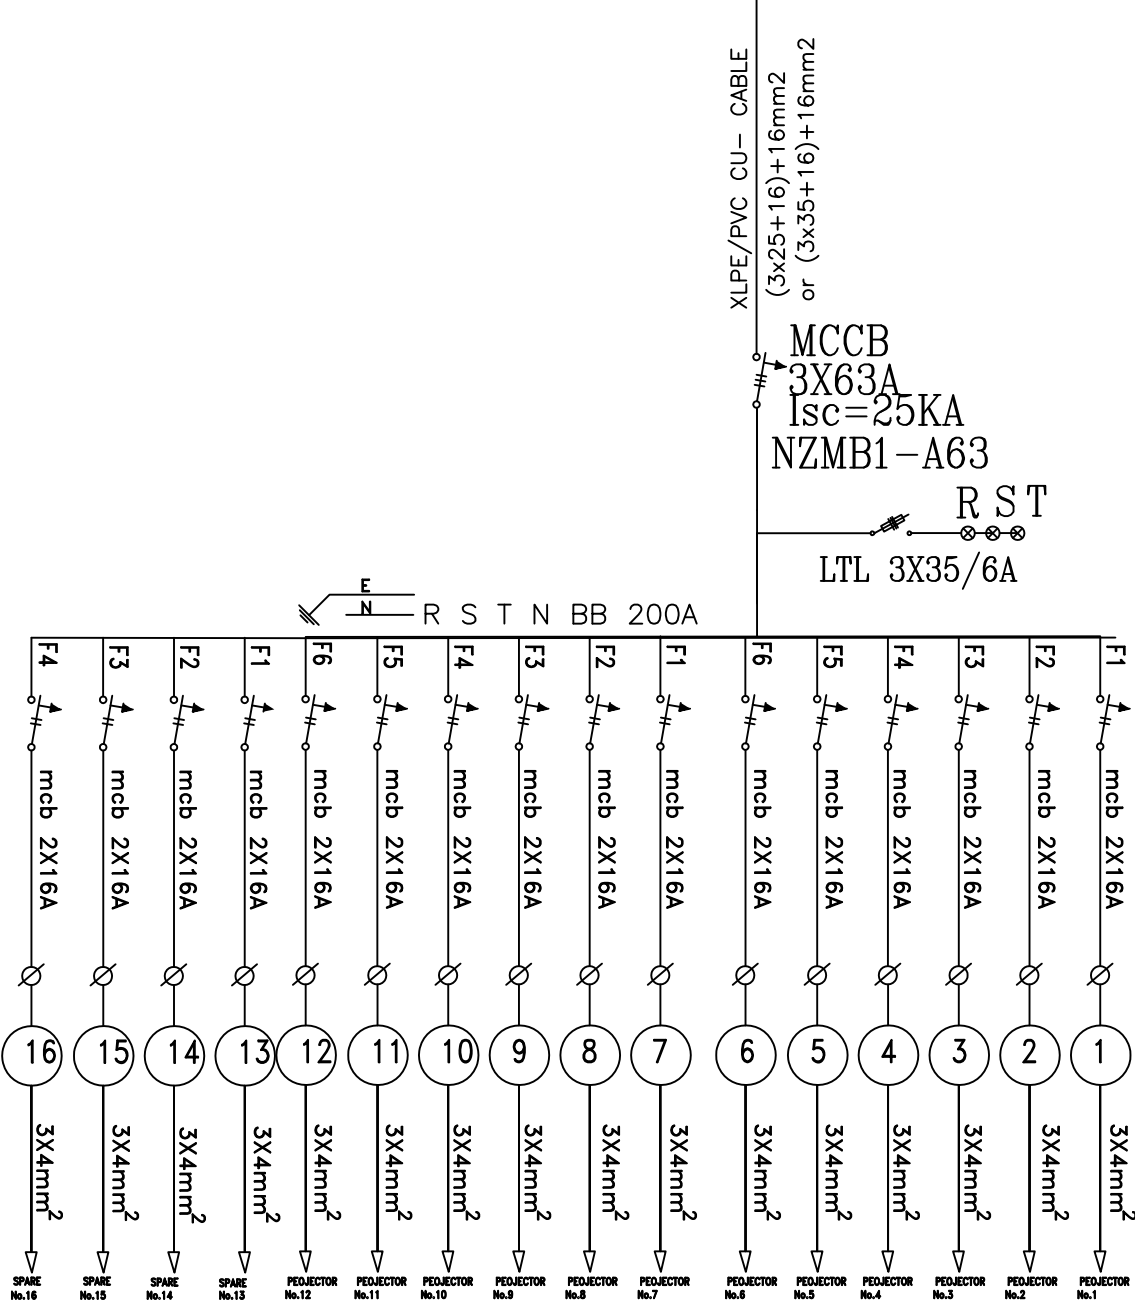

POWER PANEL FOR TOWERS PROJECTORS
SOWTH WEST TOWER
LOCATED AT THE BASEMENT OF THE TOWER

4X(TOWERS LIGHT.POWER-P)

لوحة توزيع انارة الكشافات لكل برج لوحة



FUNDED BY :
THE KINGDOM OF SAUDI ARABIA
THROUGH THE SAUDI FUND FOR
DEVELOPMENT (SFD)



LEGEND:

FOR TENDER ONLY



SYM.	NAME
GRAPHIC SCALE 0 1 2 3 4	
NO	DATE
ENG	REVISIONS

CLIENT:

EMPLOYER:

UNITED NATIONS RELIEF AND WORKS AGENCY
(UNRWA) THROUGH UNITED NATIONS
DEVELOPMENT PROGRAMME (UNDP/PAPP)

CONSULTANT:


PROJECT TITLE:

Reconstruction and repair works of more
than 150 effected houses for non-refugees
and Rehabilitation and Furniture for field
playgrounds and a culture center.

Lot#7: installation of stadium lighting for 3
playgrounds

DRAWING TITLE :
Lighting Pole Panel

PREPARED BY	SCALE	DRAWING NO.
CHECKED BY	APPROVED BY	E-10
DRAWN BY	DATE	SERIAL NO.

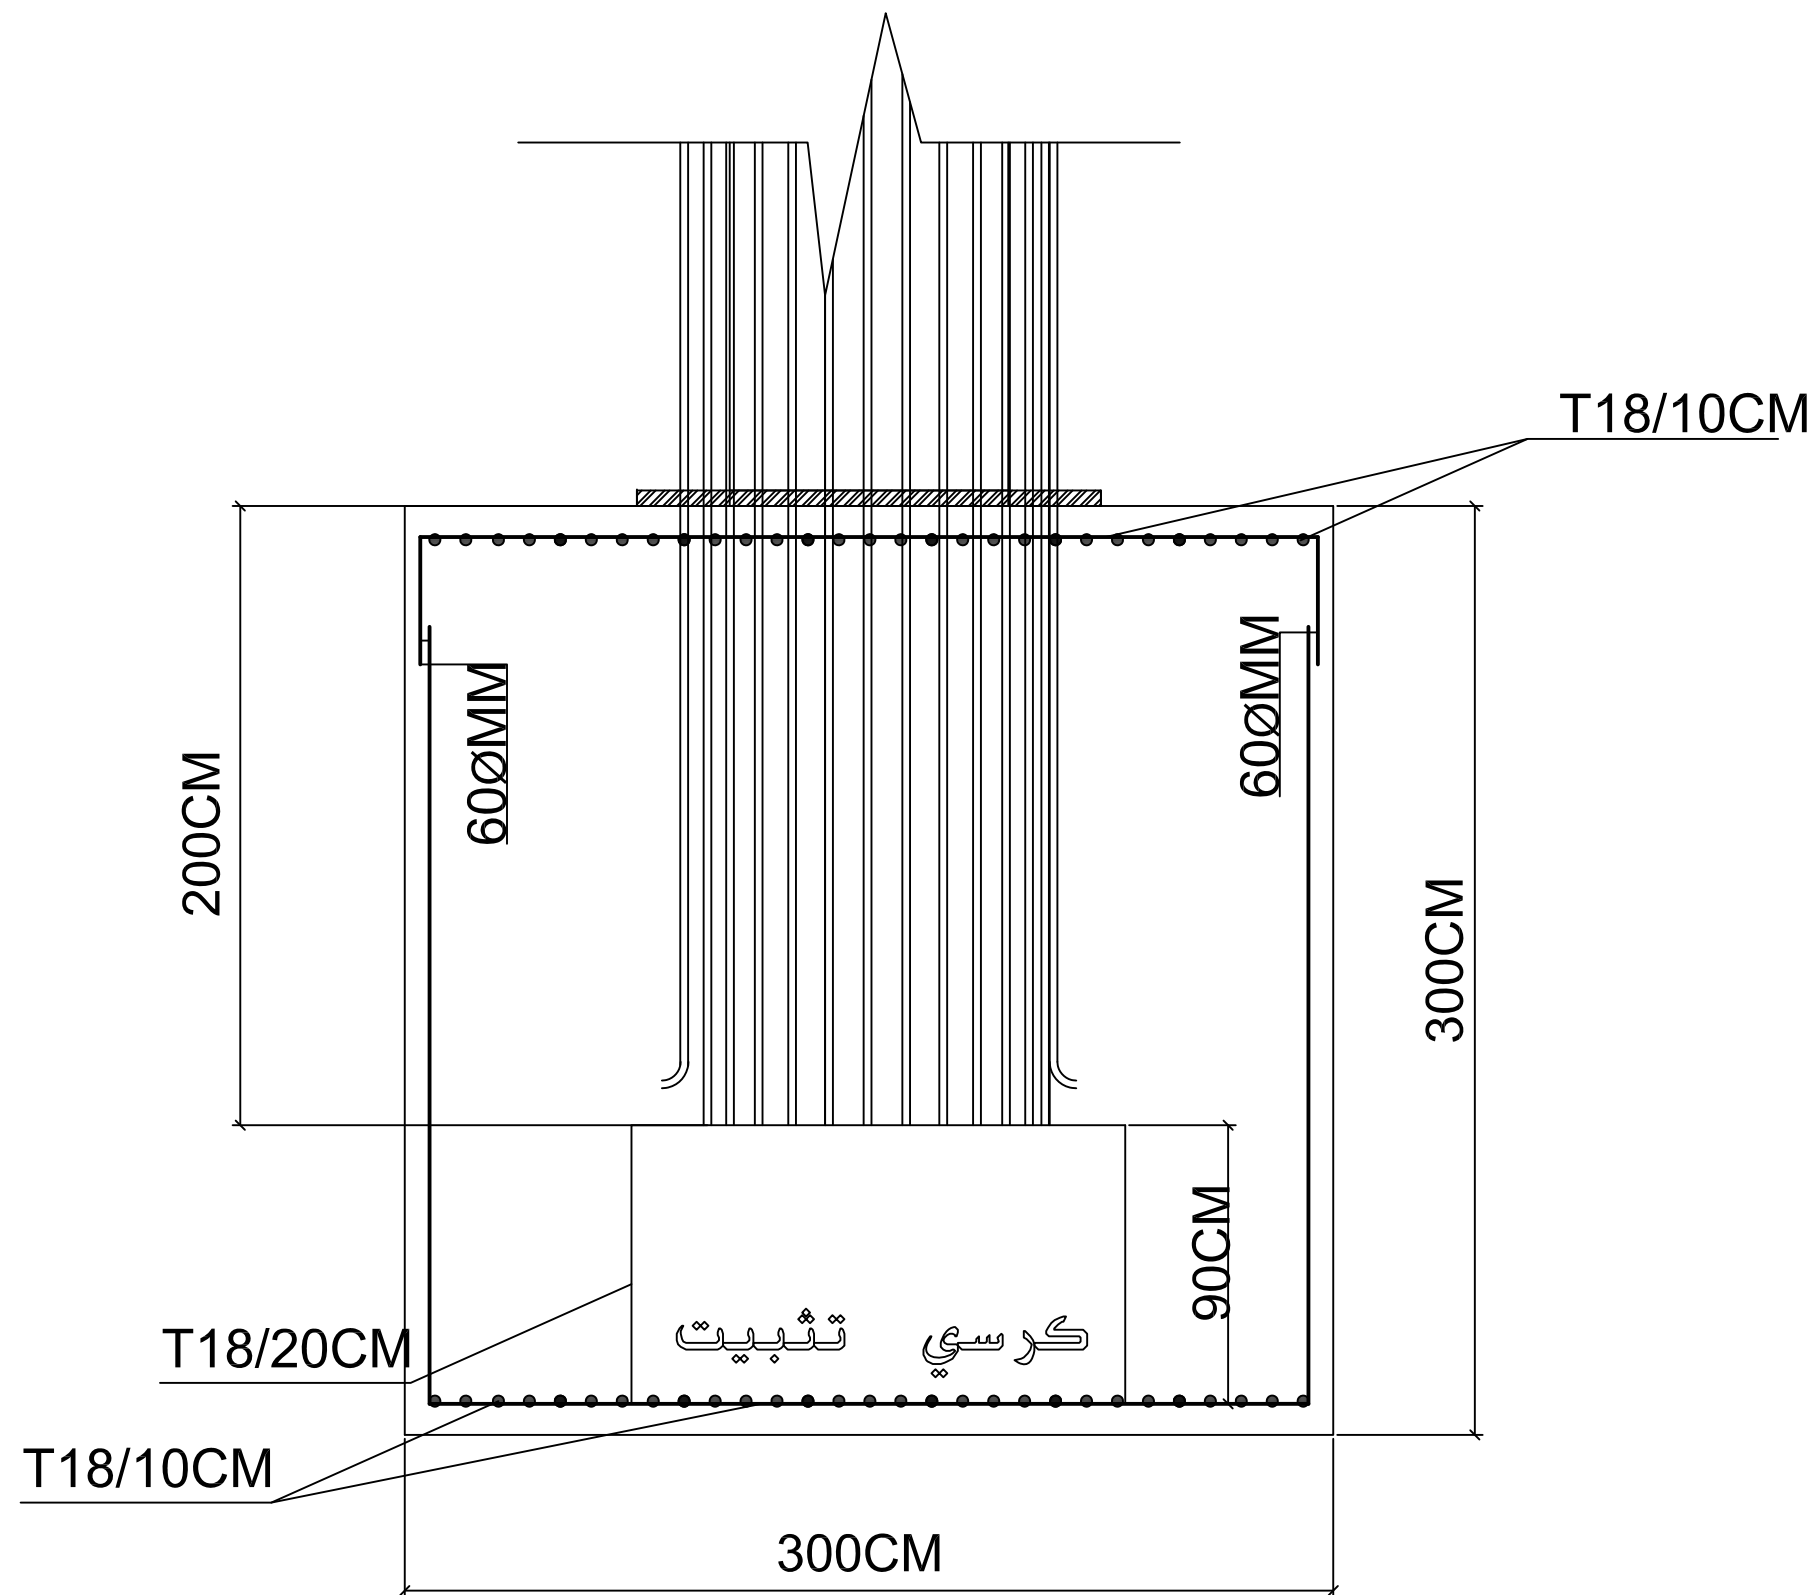

SECTION A-A




FUNDED BY :
THE KINGDOM OF SAUDI ARABIA
THROUGH THE SAUDI FUND FOR
DEVELOPMENT (SFD)



LEGEND:

FOR TENDER ONLY



SYM.		NAME	
GRAPHIC SCALE			
NO	DATE	ENG	REVISIONS

CLIENT:

EMPLOYER:

UNITED NATIONS RELIEF AND WORKS AGENCY
(UNRWA) THROUGH UNITED NATIONS
DEVELOPMENT PROGRAMME (UNDP/PAPP)

CONSULTANT:


PROJECT TITLE:

Reconstruction and repair works of more
than 150 effected houses for non-refugees
and Rehabilitation and Furniture for field
playgrounds and a culture center.

Lot#7: installation of stadium lighting for 3
playgrounds

DRAWING TITLE:
Pole Base Details 1

PREPARED BY	SCALE	DRAWING NO.
CHECKED BY	APPROVED BY	E-11
DRAWN BY	DATE	SERIAL NO.

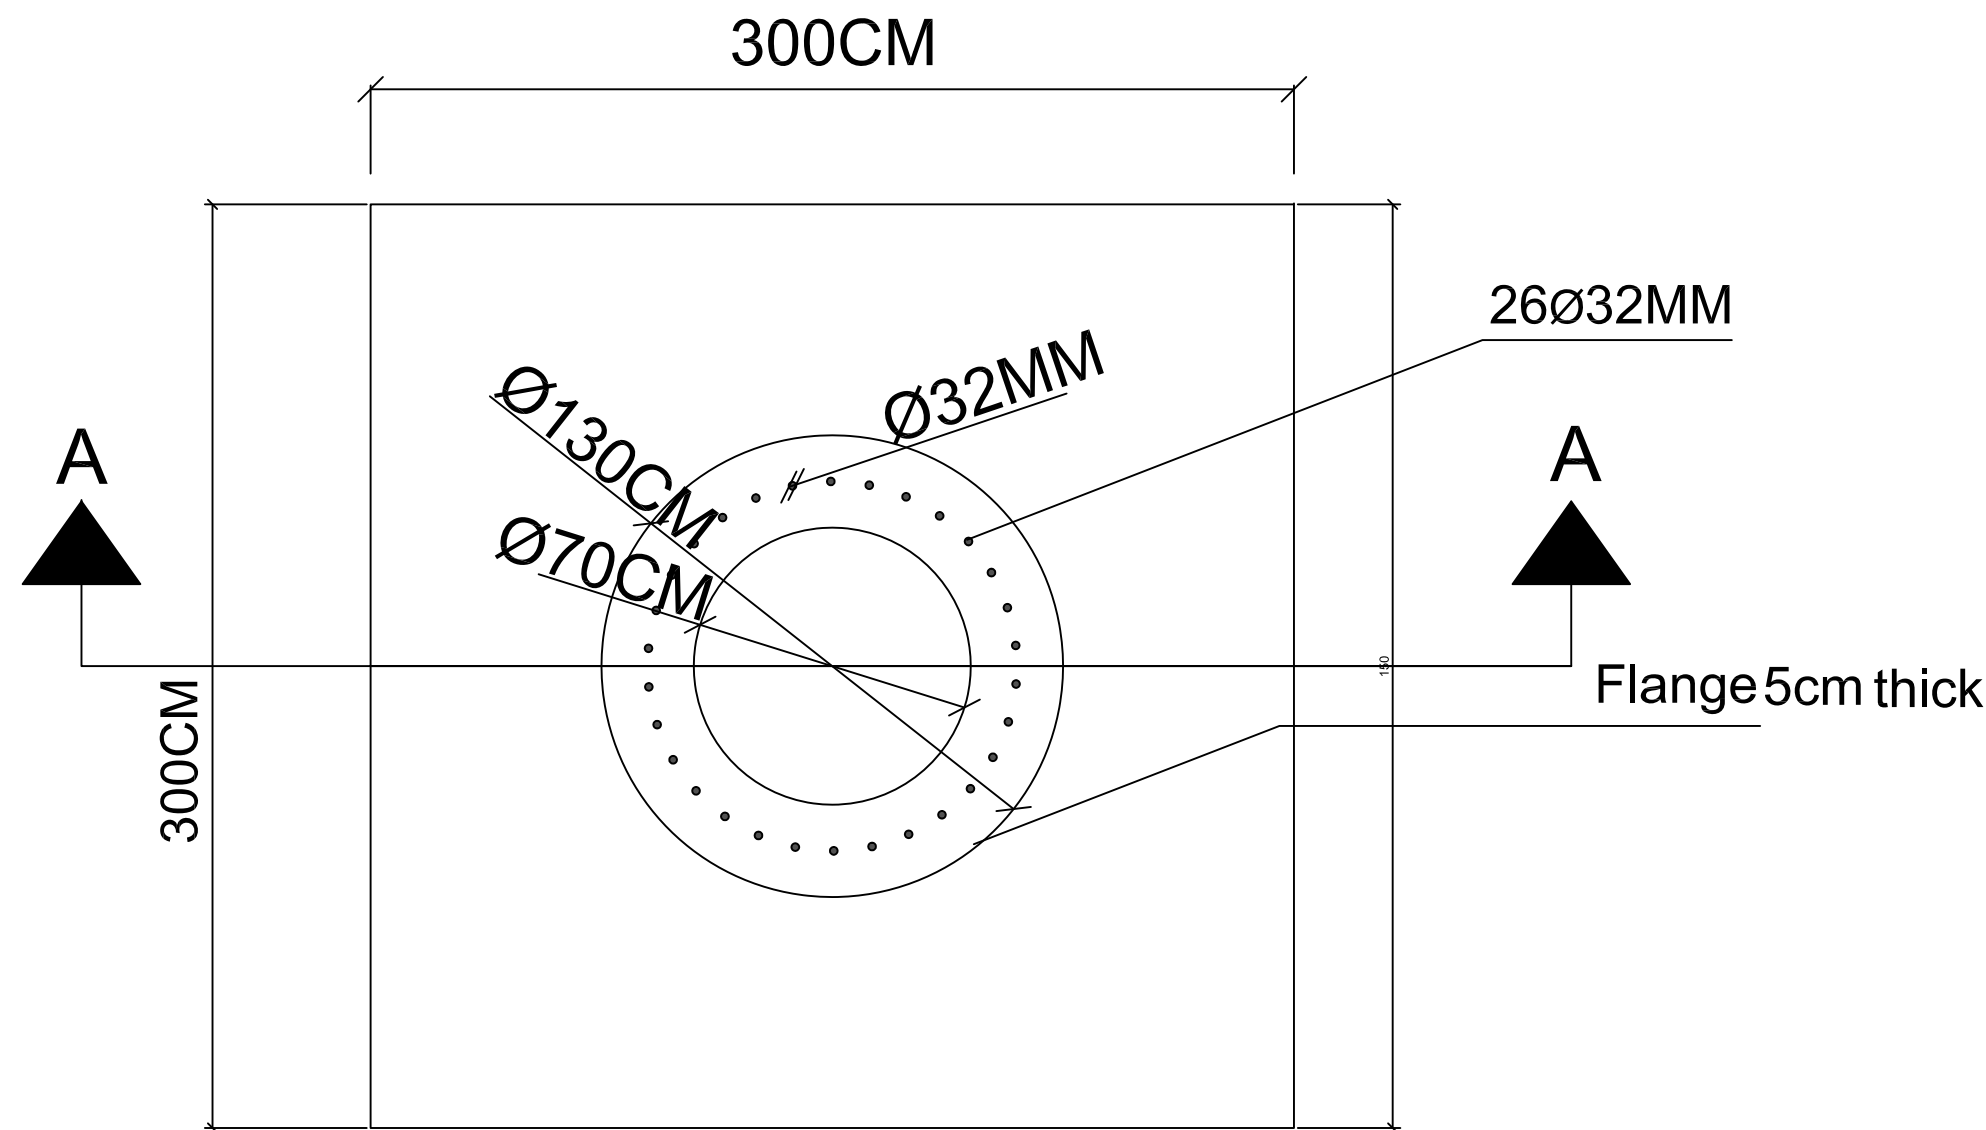

قاعدة العمود في الباطون

تفصيلة اتصال بلاطة برج الإنارة بقاعدة الباطون



FUNDED BY :
THE KINGDOM OF SAUDI ARABIA
THROUGH THE SAUDI FUND FOR
DEVELOPMENT (SFD)



LEGEND:

FOR TENDER ONLY



SYM.		NAME	
GRAPHIC SCALE			
		0 1 2 3 4	
NO.	DATE	ENG.	REVISIONS

CLIENT:

EMPLOYER:

UNITED NATIONS RELIEF AND WORKS AGENCY
(UNRWA) THROUGH UNITED NATIONS
DEVELOPMENT PROGRAMME (UNDP/PAPP)

CONSULTANT:

PROJECT TITLE:

Reconstruction and repair works of more than 150 effected houses for non-refugees and Rehabilitation and Furniture for field playgrounds and a culture center.

Lot#7: installation of stadium lighting for 3 playgrounds

DRAWING TITLE:

Pole Base Details 2

PREPARED BY	SCALE	DRAWING NO.
CHECKED BY	APPROVED BY	E-12
DRAWN BY	DATE	SERIAL NO.



FUNDED BY:
THE KINGDOM OF SAUDI ARABIA
THROUGH THE SAUDI FUND FOR
DEVELOPMENT (SFD)



LEGEND:

FOR TENDER ONLY



SYM.	NAME
GRAPHIC SCALE	0 1 2 3 4
NO	DATE
ENG	REVISIONS

CLIENT:

EMPLOYER:

UNITED NATIONS RELIEF AND WORKS AGENCY
(UNRWA) THROUGH UNITED NATIONS
DEVELOPMENT PROGRAMME (UNDP/PAPP)


CONSULTANT:

PROJECT TITLE:


Reconstruction and repair works of more
than 150 effected houses for non-refugees
and Rehabilitation and Furniture for field
playgrounds and a culture center.

Lot#7: installation of stadium lighting for 3
playgrounds


DRAWING TITLE :		
pole panel details 2		
PREPARED BY	SCALE	DRAWING NO.
CHECKED BY	APPROVED BY	E-14
DRAWN BY	DATE	SERIAL NO.

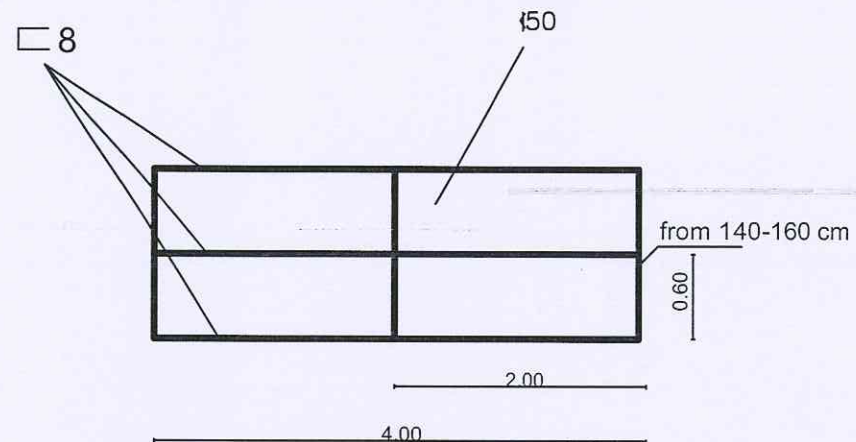


الواجهة الأمامية

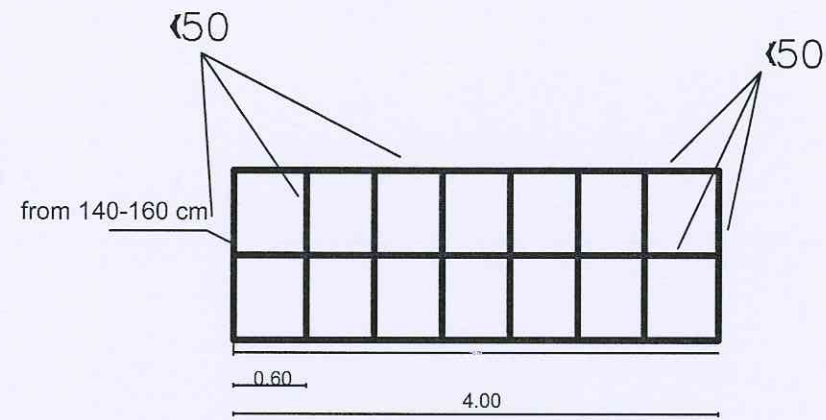


الواجهة الخلفية


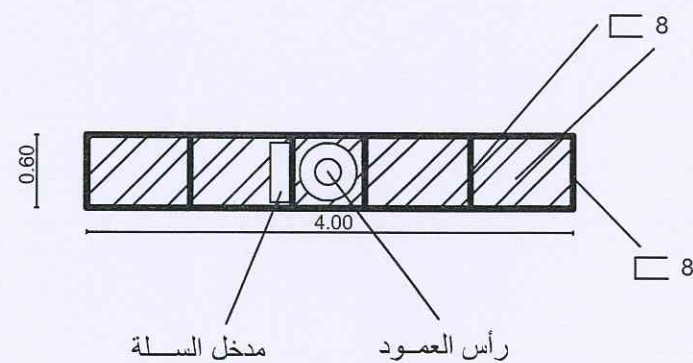


أرضية السلة

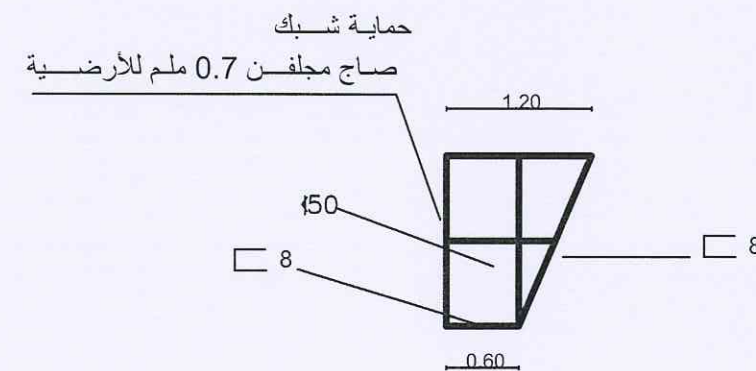

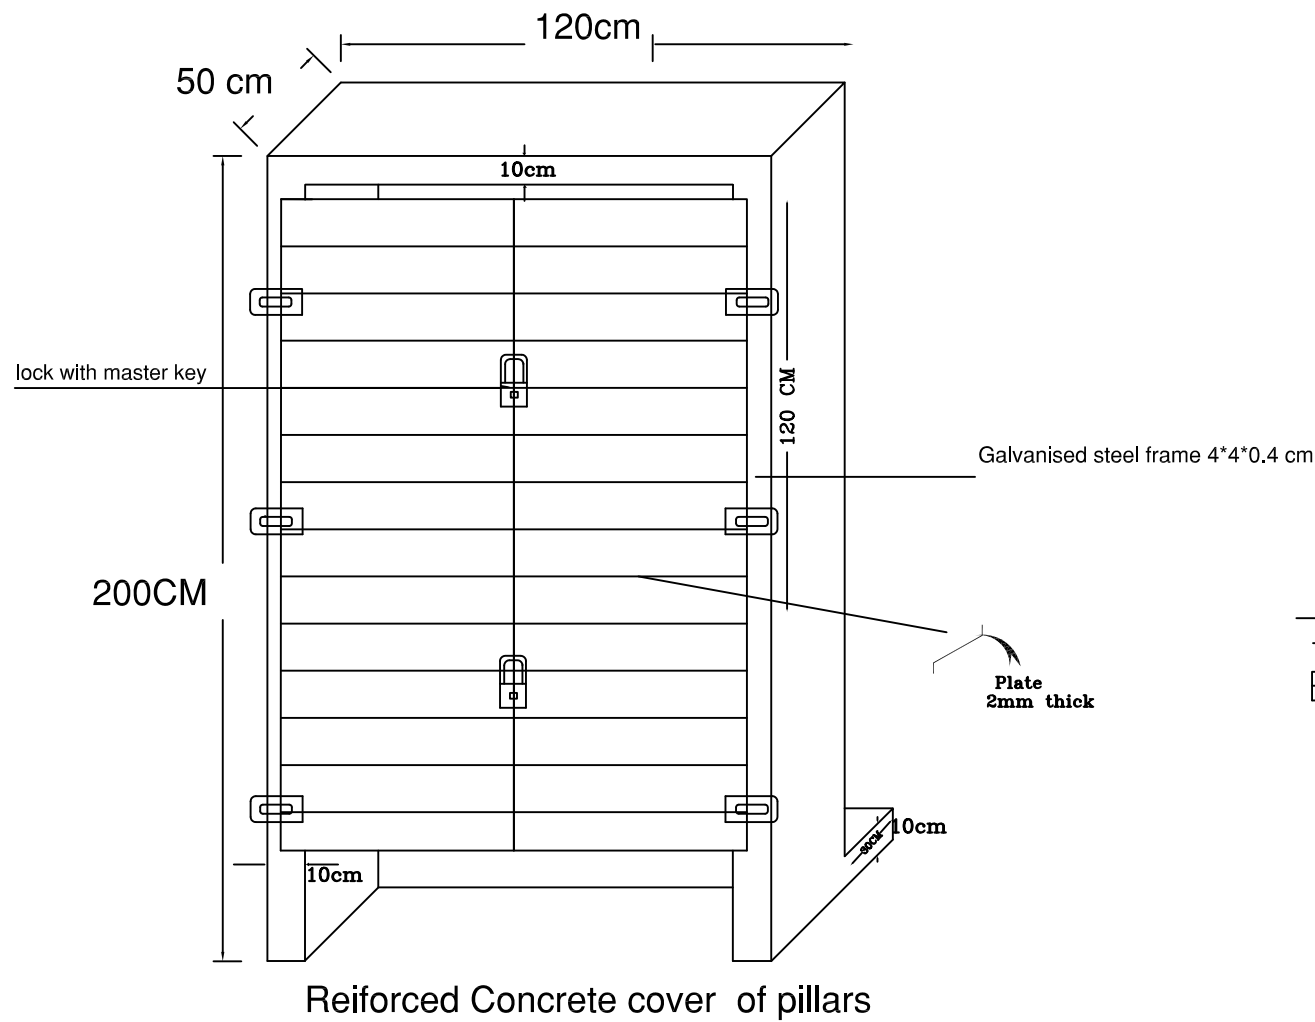

$$E < 1.5$$

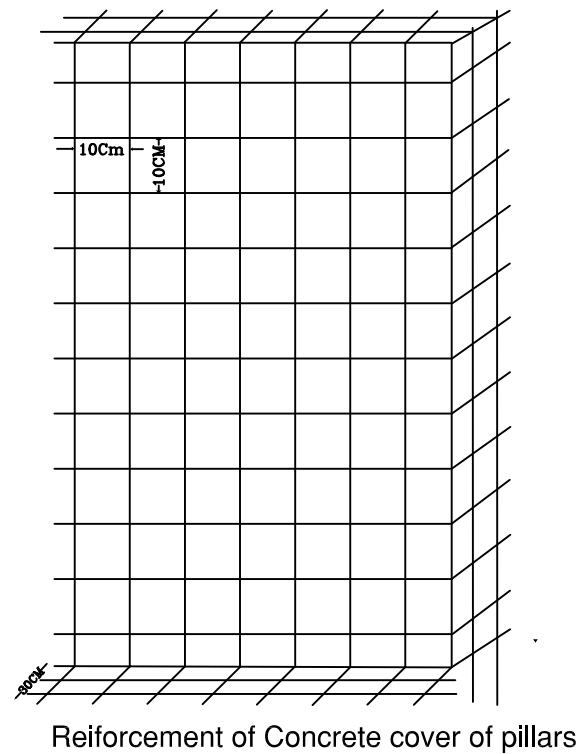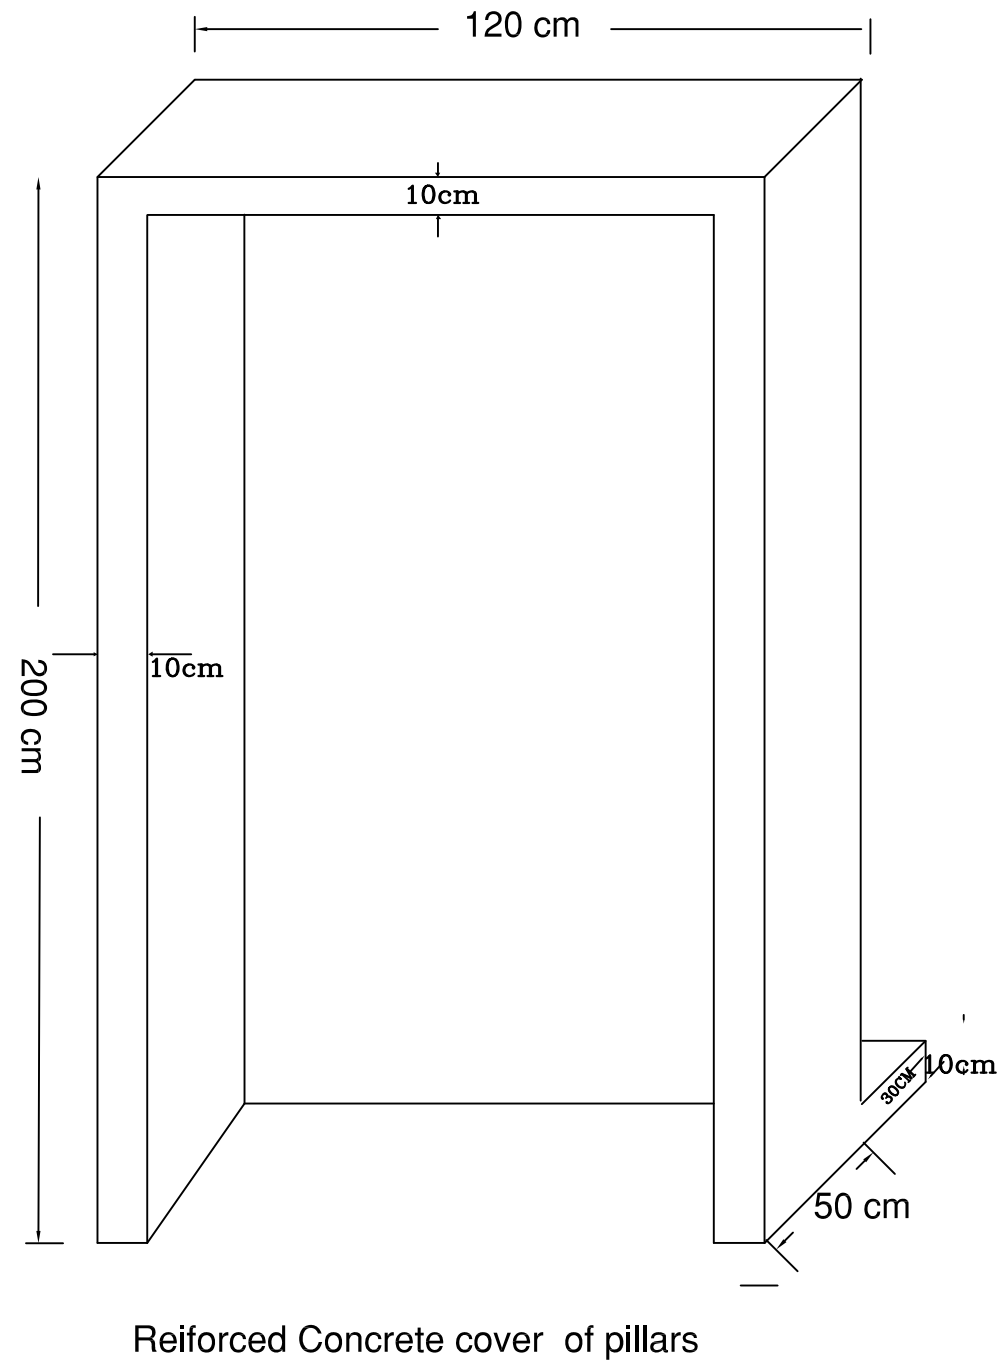

Steelreinforcement 10mm/10 cm in both directions




FUNDED BY :
THE KINGDOM OF SAUDI ARABIA
THROUGH THE SAUDI FUND FOR
DEVELOPMENT (SFD)



LEGEND:

FOR TENDER ONLY



SYM.		NAME	
GRAPHIC SCALE			
NO	DATE	ENG	REVISIONS

CLIENT:

EMPLOYER:

UNITED NATIONS RELIEF AND WORKS AGENCY
(UNRWA) THROUGH UNITED NATIONS
DEVELOPMENT PROGRAMME (UNDP/PAPP)

CONSULTANT:



PROJECT TITLE:

Reconstruction and repair works of more
than 150 effected houses for non-refugees
and Rehabilitation and Furniture for field
playgrounds and a culture center.

Lot#7: installation of stadium lighting for 3
playgrounds

DRAWING TITLE:
Structure for pillars

PREPARED BY	SCALE	DRAWING NO.
CHECKED BY	APPROVED BY	E-15
DRAWN BY	DATE	SERIAL NO.

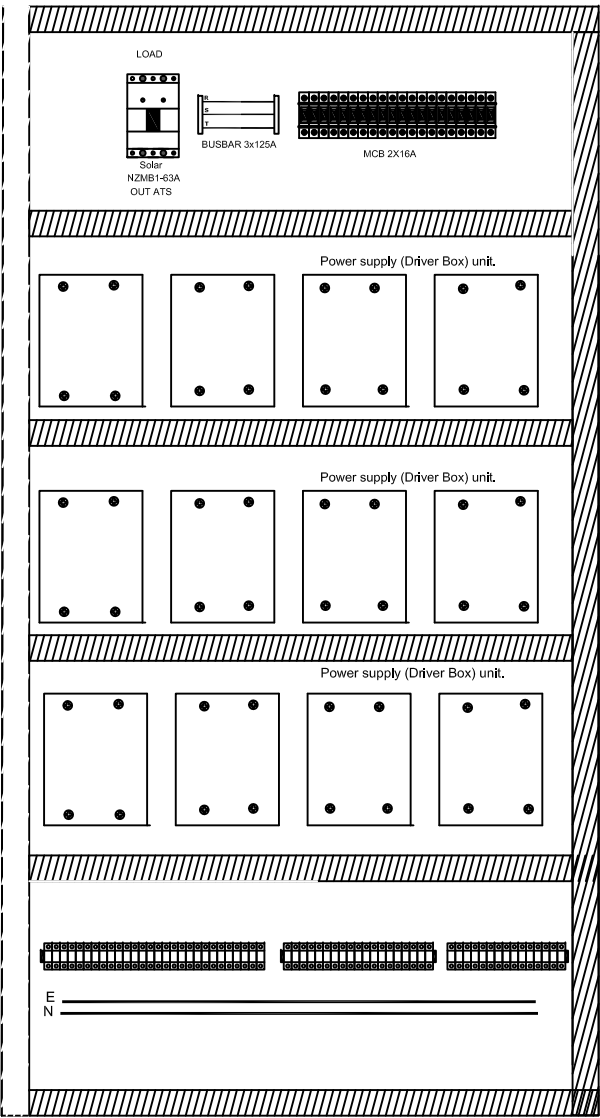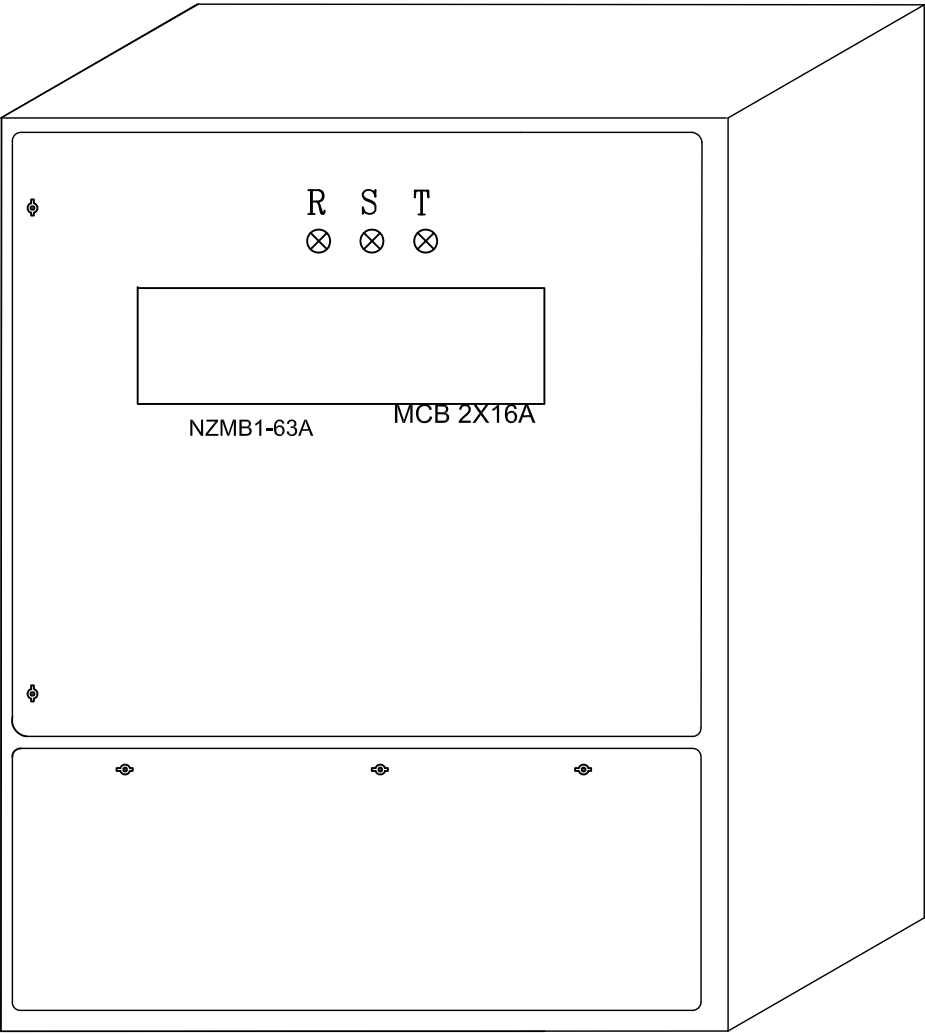

Electrical Pillar

Details of electrical pillar




FUNDED BY :
THE KINGDOM OF SAUDI ARABIA
THROUGH THE SAUDI FUND FOR
DEVELOPMENT (SFD)



LEGEND:

FOR TENDER ONLY



SYM.		NAME	
GRAPHIC SCALE			
NO	DATE	ENG	REVISIONS

CLIENT:

EMPLOYER:

UNITED NATIONS RELIEF AND WORKS AGENCY
(UNRWA) THROUGH UNITED NATIONS
DEVELOPMENT PROGRAMME (UNDP/PAPP)



CONSULTANT:

PROJECT TITLE:

Reconstruction and repair works of more
than 150 effected houses for non-refugees
and Rehabilitation and Furniture for field
playgrounds and a culture center.

Lot#7: installation of stadium lighting for 3
playgrounds

DRAWING TITLE:			
Electrical pillar			
PREPARED BY	SCALE	DRAWING NO.	
CHECKED BY	APPROVED BY	E-16	
DRAWN BY	DATE	SERIAL NO.	

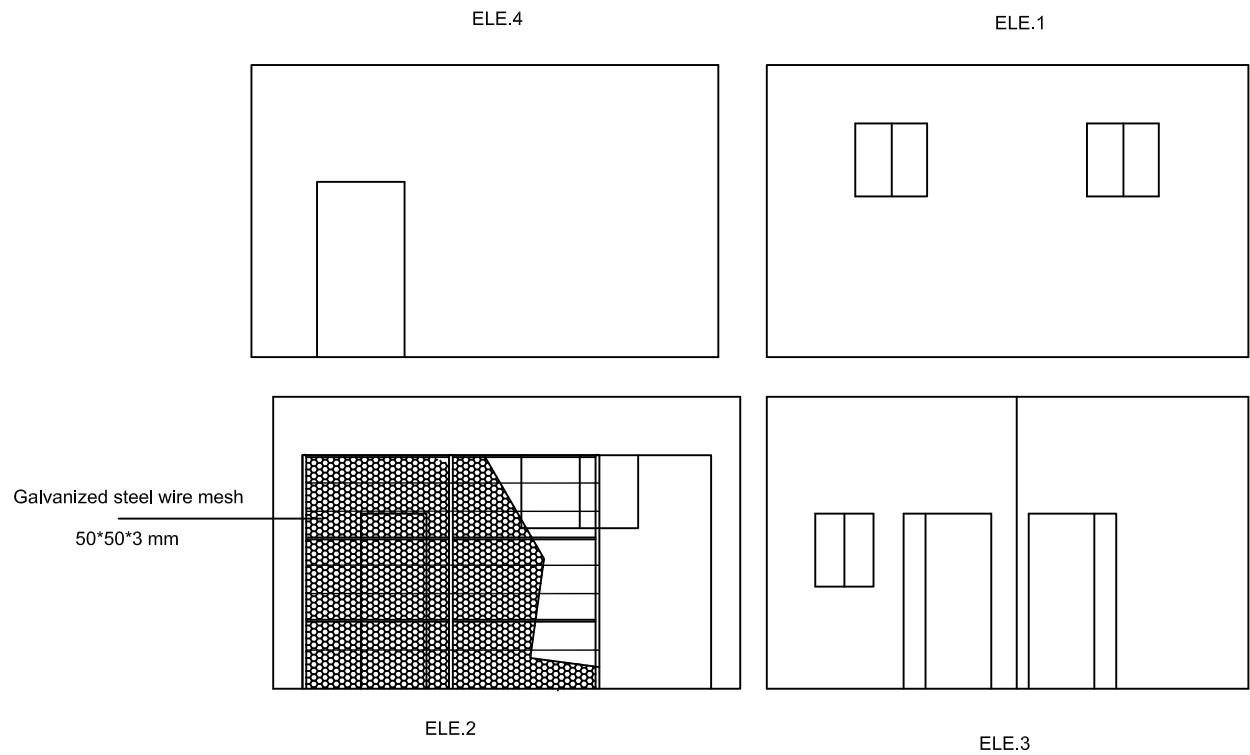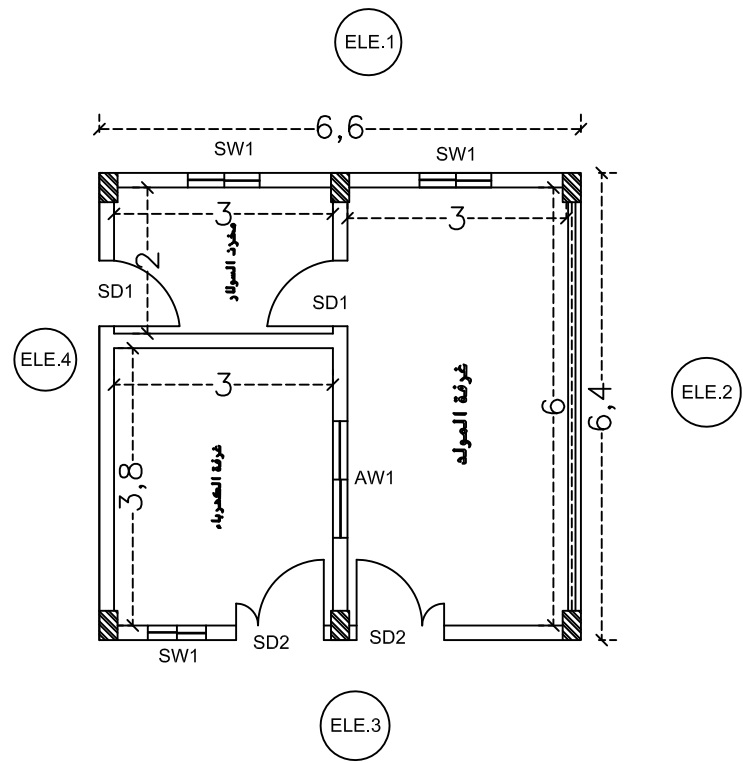

FUNDED BY :
THE KINGDOM OF SAUDI ARABIA
THROUGH THE SAUDI FUND FOR
DEVELOPMENT (SFD)



LEGEND:

FOR TENDER ONLY



SYM.	NAME
GRAPHIC SCALE 0 1 2 3 4	
NO.	DATE
ENG.	REVISIONS

CLIENT:

EMPLOYER:

UNITED NATIONS RELIEF AND WORKS AGENCY
(UNRWA) THROUGH UNITED NATIONS
DEVELOPMENT PROGRAMME (UNDP/PAPP)

CONSULTANT:

PROJECT TITLE:

Reconstruction and repair works of more
than 150 effected houses for non-refugees
and Rehabilitation and Furniture for field
playgrounds and a culture center.

Lot#7: installation of stadium lighting for 3
playgrounds

DRAWING TITLE :
Electrical room

PREPARED BY	SCALE	DRAWING NO.
CHECKED BY	APPROVED BY	Ar-01
DRAWN BY	DATE	SERIAL NO.



FUNDED BY :
THE KINGDOM OF SAUDI ARABIA
THROUGH THE SAUDI FUND FOR
DEVELOPMENT (SFD)



LEGEND:

FOR TENDER ONLY



SYM.		NAME	
GRAPHIC SCALE		0 1 2 3 4	
NO	DATE	ENG	REVISIONS

CLIENT:




EMPLOYER:
UNITED NATIONS RELIEF AND WORKS AGENCY
(UNRWA) THROUGH UNITED NATIONS
DEVELOPMENT PROGRAMME (UNDP/PAPP)

CONSULTANT:


PROJECT TITLE:
Reconstruction and repair works of more
than 150 effected houses for non-refugees
and Rehabilitation and Furniture for field
playgrounds and a culture center.

Lot#7: installation of stadium lighting for 3
playgrounds




DRAWING TITLE : Electrical room		
PREPARED BY	SCALE	DRAWING NO.
CHECKED BY	APPROVED BY	C-01
DRAWN BY	DATE	SERIAL NO.

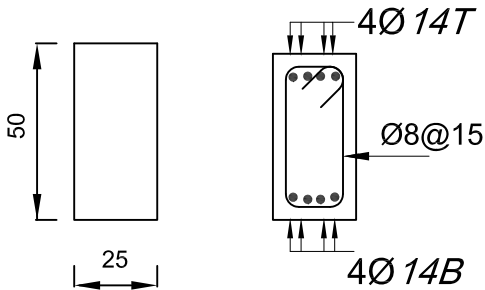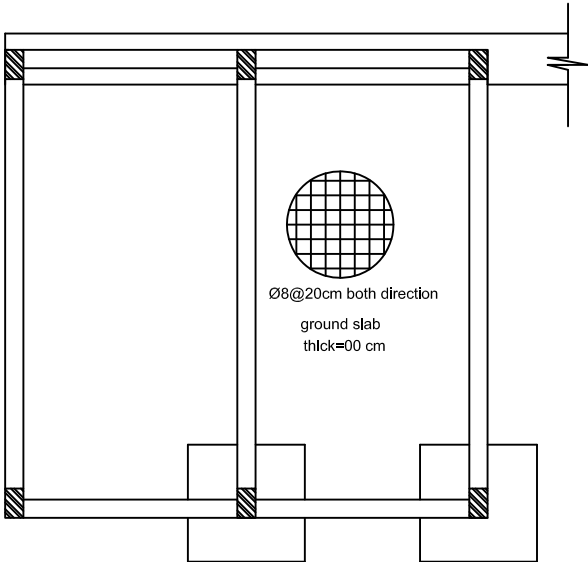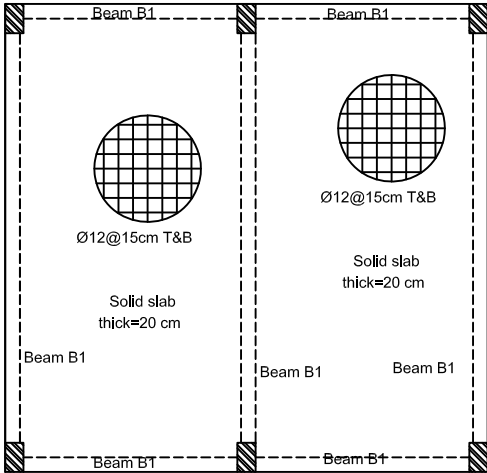


Beam B1
(1:25)

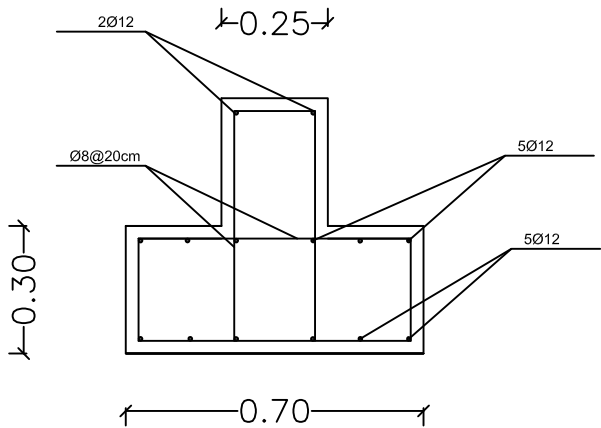

Typical Detail to isolated footing

 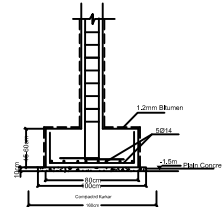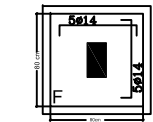

6Ø14

 

34

St. Ø8x122

Typical columns
Dim. 40*25 cm



FUNDED BY :

**THE KINGDOM OF SAUDI ARABIA
THROUGH THE SAUDI FUND FOR
DEVELOPMENT (SFD)**



LEGEND:

FOR TENDER ONLY



SYM.			NAME		
GRAPHIC SCALE					
NO	DATE	ENG	REVISIONS		

CLIENT:

EMPLOYER:

UNITED NATIONS RELIEF AND WORKS AGENCY
(UNRWA) THROUGH UNITED NATIONS
DEVELOPMENT PROGRAMME (UNDP/PAPP)

CONSULTANT:



PROJECT TITLE:

Reconstruction and repair works of more than 150 effected houses for non-refugees and Rehabilitation and Furniture for field playgrounds and a culture center.




Lot#7: installation of stadium lighting for 3 playgrounds

DRAWING TITLE : Details in Electrical room	
---	--

PREPARED BY	SCALE	DRAWING NO. D-01
CHECKED BY	APPROVED BY	
DRAWN BY	DATE	SERIAL NO.

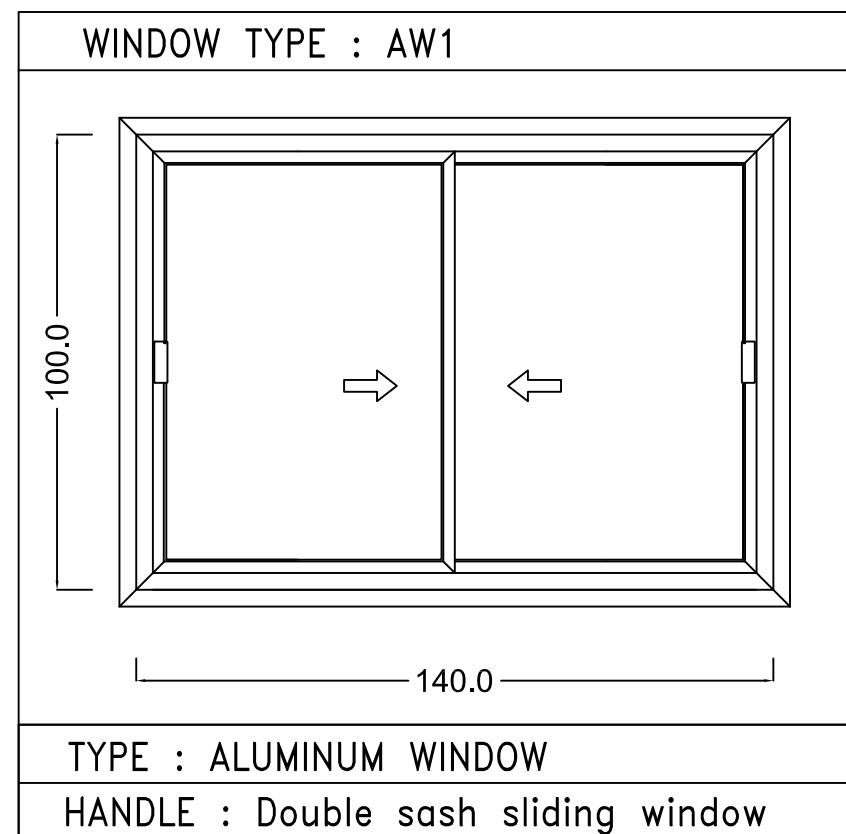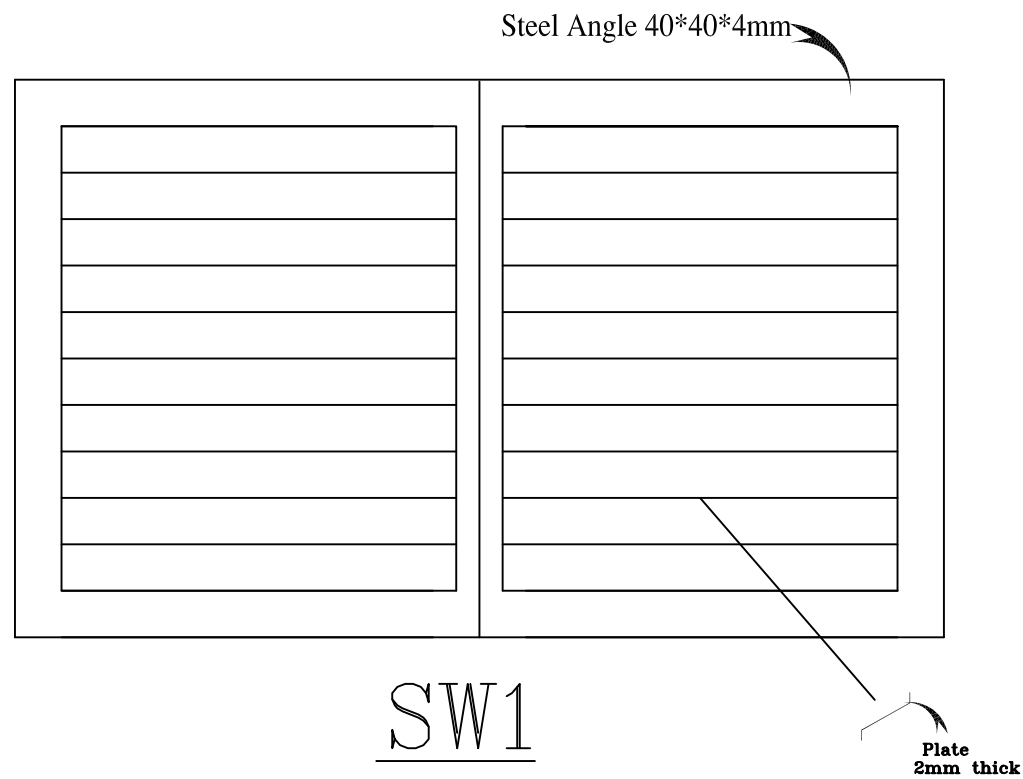

STEEL PLATE DOOR TYPE SD1 DETAIL

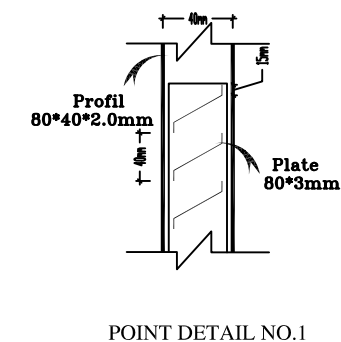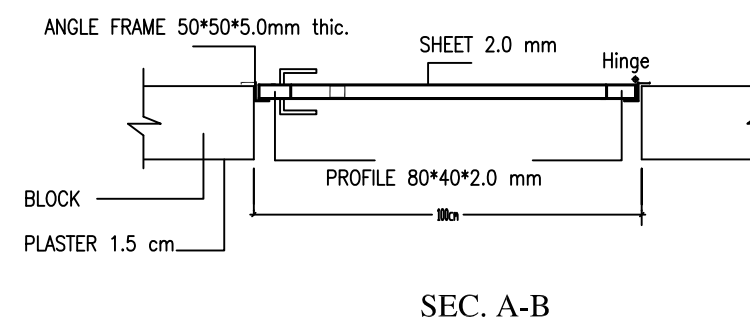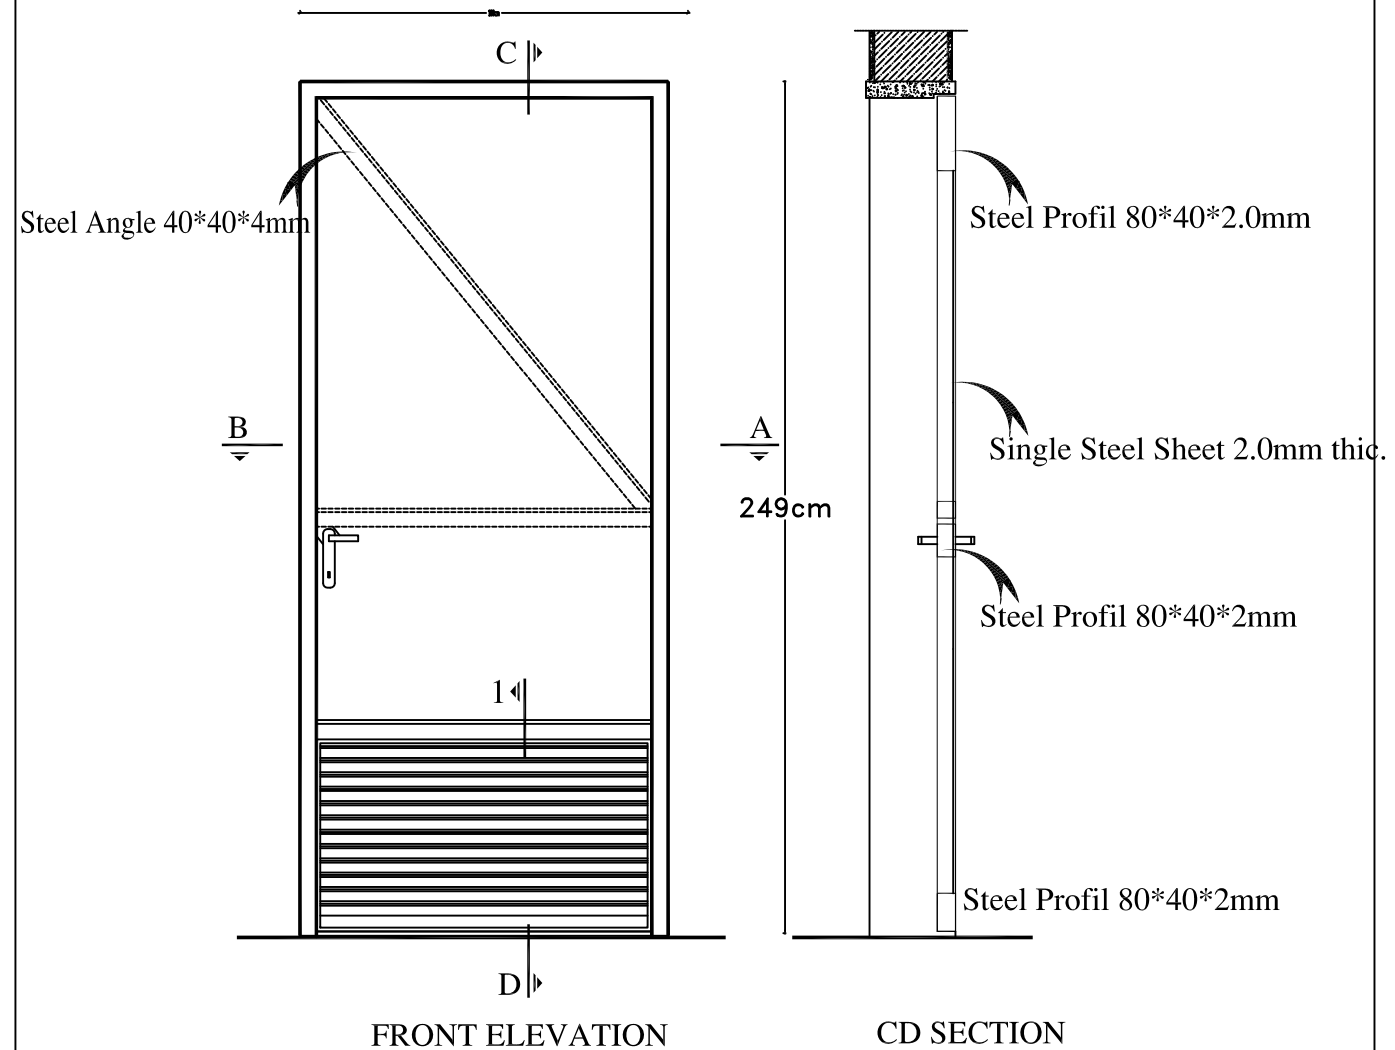

SD1



FUNDED BY :
THE KINGDOM OF SAUDI ARABIA
THROUGH THE SAUDI FUND FOR
DEVELOPMENT (SFD)



LEGEND:

FOR TENDER ONLY



SYM.	NAME
GRAPHIC SCALE 0 1 2 3 4	
NO.	DATE
ENG.	REVISIONS

CLIENT:

EMPLOYER:
UNITED NATIONS RELIEF AND WORKS AGENCY
(UNRWA) THROUGH UNITED NATIONS
DEVELOPMENT PROGRAMME (UNDP/PAPP)


CONSULTANT:

PROJECT TITLE:
Reconstruction and repair works of more
than 150 effected houses for non-refugees
and Rehabilitation and Furniture for field
playgrounds and a culture center.


Lot#7: installation of stadium lighting for 3
playgrounds

DRAWING TITLE :
Details in Electrical room


PREPARED BY	SCALE	DRAWING NO.
CHECKED BY	APPROVED BY	D-02
DRAWN BY	DATE	SERIAL NO.

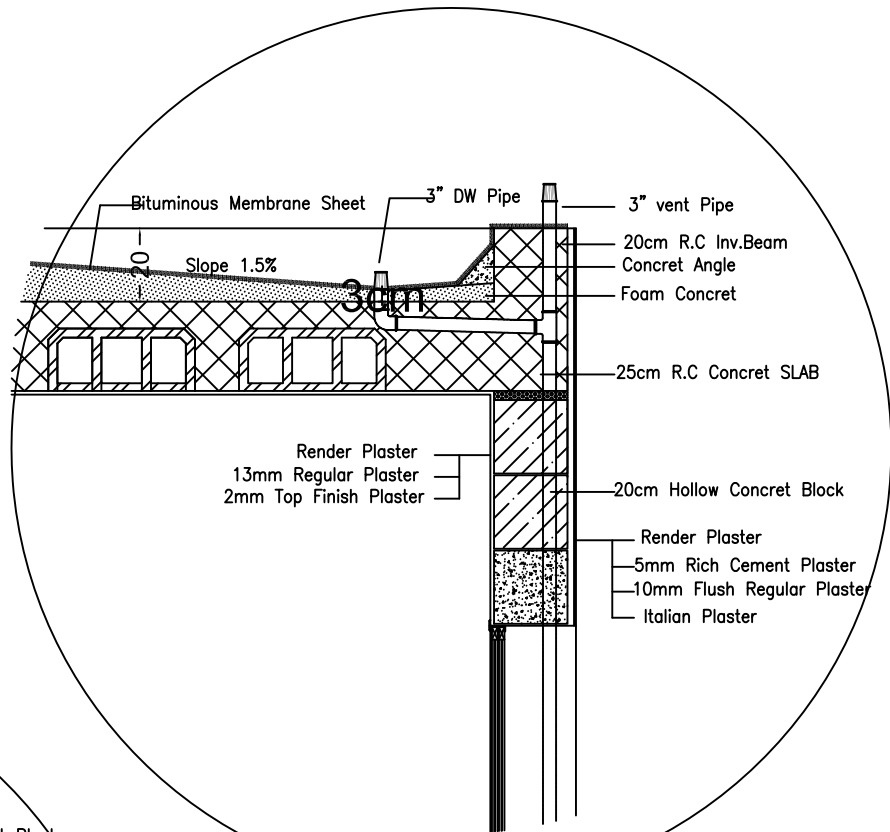


شيء

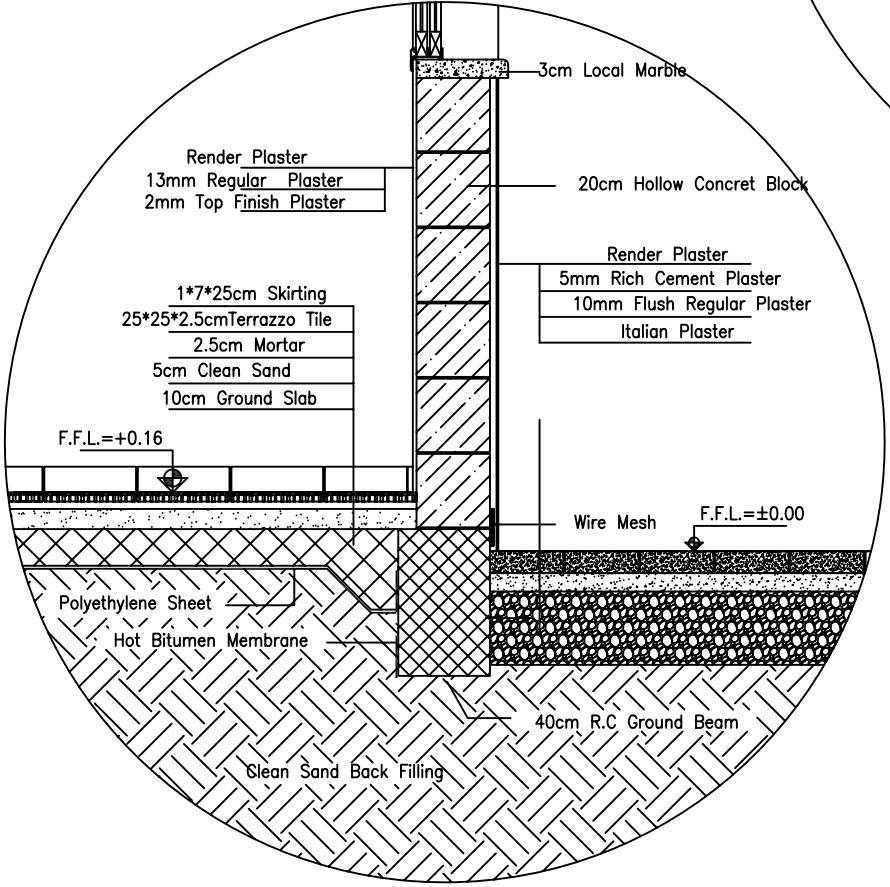


شيء

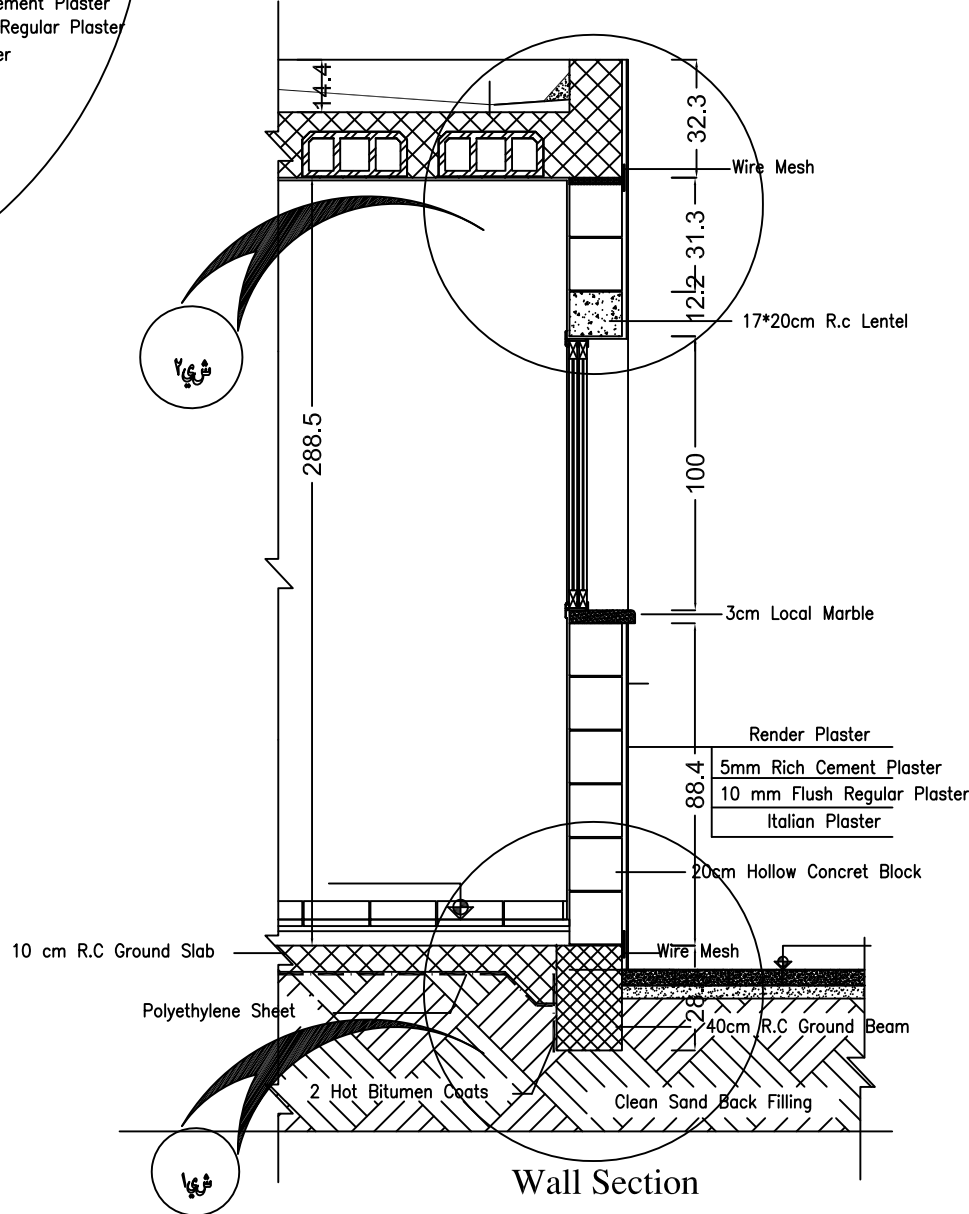


Wall Section

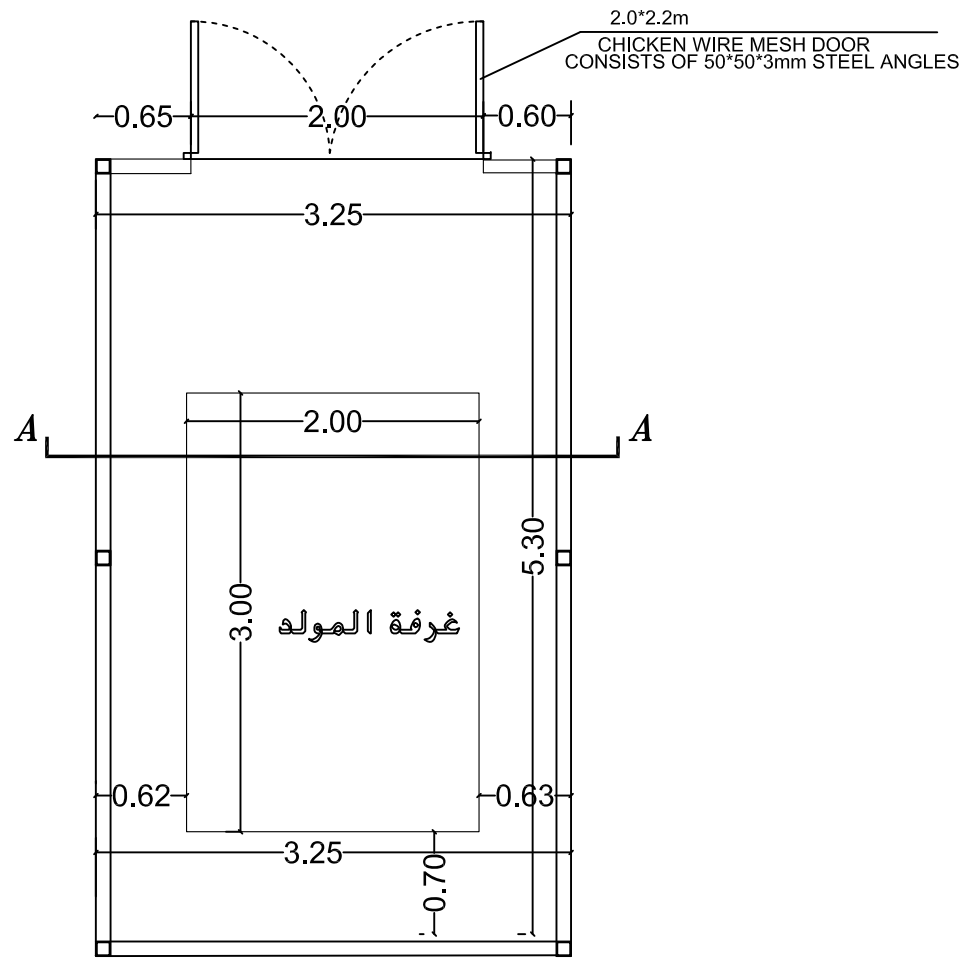


PLAN FOR
GENERATOR SHED & FENCE
SCALE 1 :50

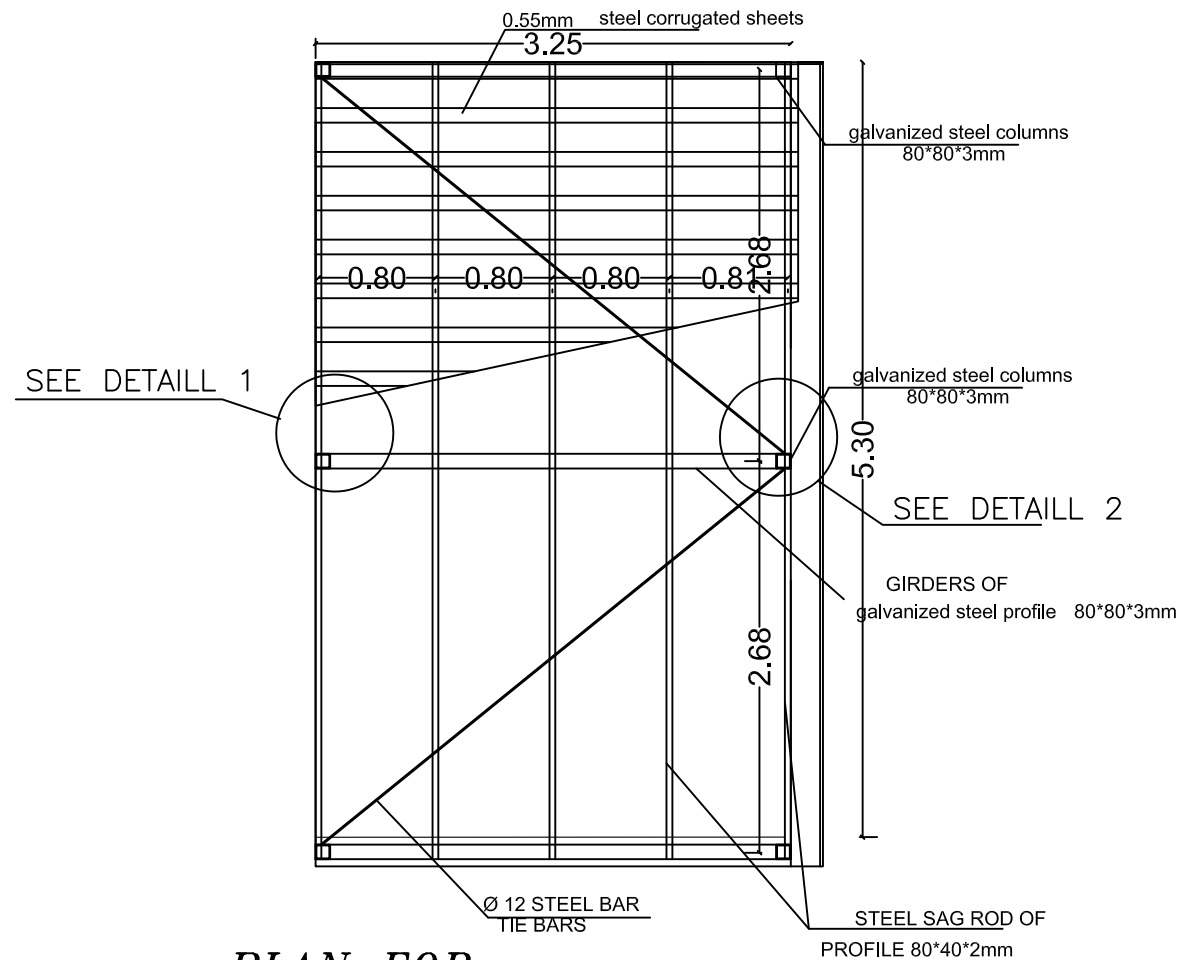

PLAN FOR
GENERATOR SHED & FENCE
SCALE 1 :50

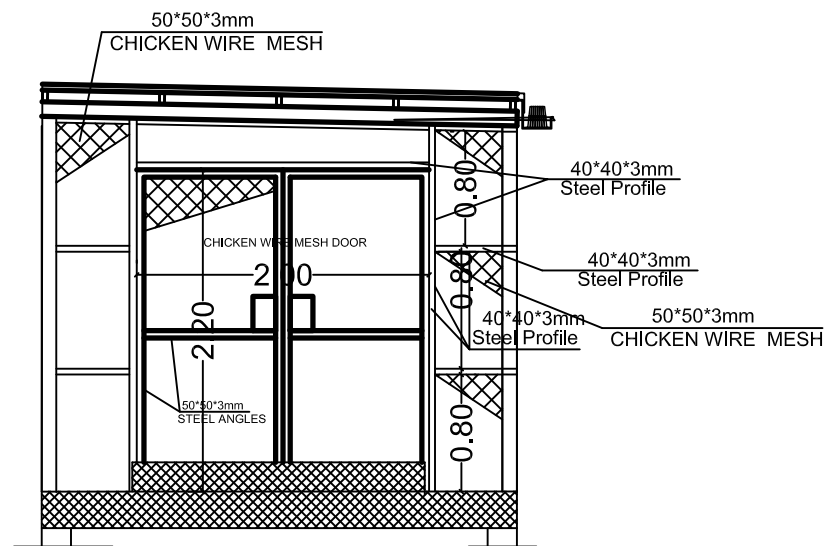

SECTION A-A
SCALE 1 :50

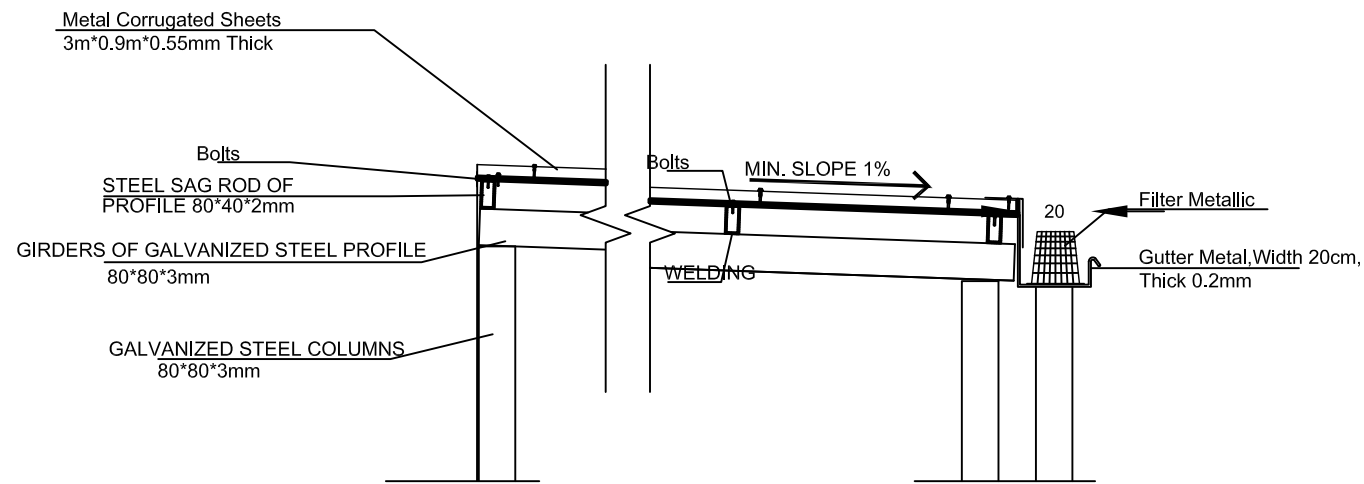

DETAIL 1

DETAIL 2

Details in Electrical Generator Shed Al-Dorrah & Khanyounis Playgrounds



FUNDED BY :
THE KINGDOM OF SAUDI ARABIA
THROUGH THE SAUDI FUND FOR
DEVELOPMENT (SFD)



LEGEND:

FOR TENDER ONLY



SYM.	NAME
GRAPHIC SCALE 0 1 2 3 4	
NO	DATE
ENG	REVISIONS

CLIENT:

EMPLOYER:

UNITED NATIONS RELIEF AND WORKS AGENCY
(UNRWA) THROUGH UNITED NATIONS
DEVELOPMENT PROGRAMME (UNDP/PAPP)

CONSULTANT:

PROJECT TITLE:

Reconstruction and repair works of more
than 150 effected houses for non-refugees
and Rehabilitation and Furniture for field
playgrounds and a culture center.

Lot#7: installation of stadium lighting for 3
playgrounds

DRAWING TITLE:
Details in Electrical Generator Shed

PREPARED BY	SCALE	DRAWING NO.
CHECKED BY	APPROVED BY	D-03
DRAWN BY	DATE	SERIAL NO.