


No	DATE	REVISION
0		ISSUED FOR TENDER PURPOSE ONLY
1		ISSUED FOR CONSTRUCTION
2		
3		

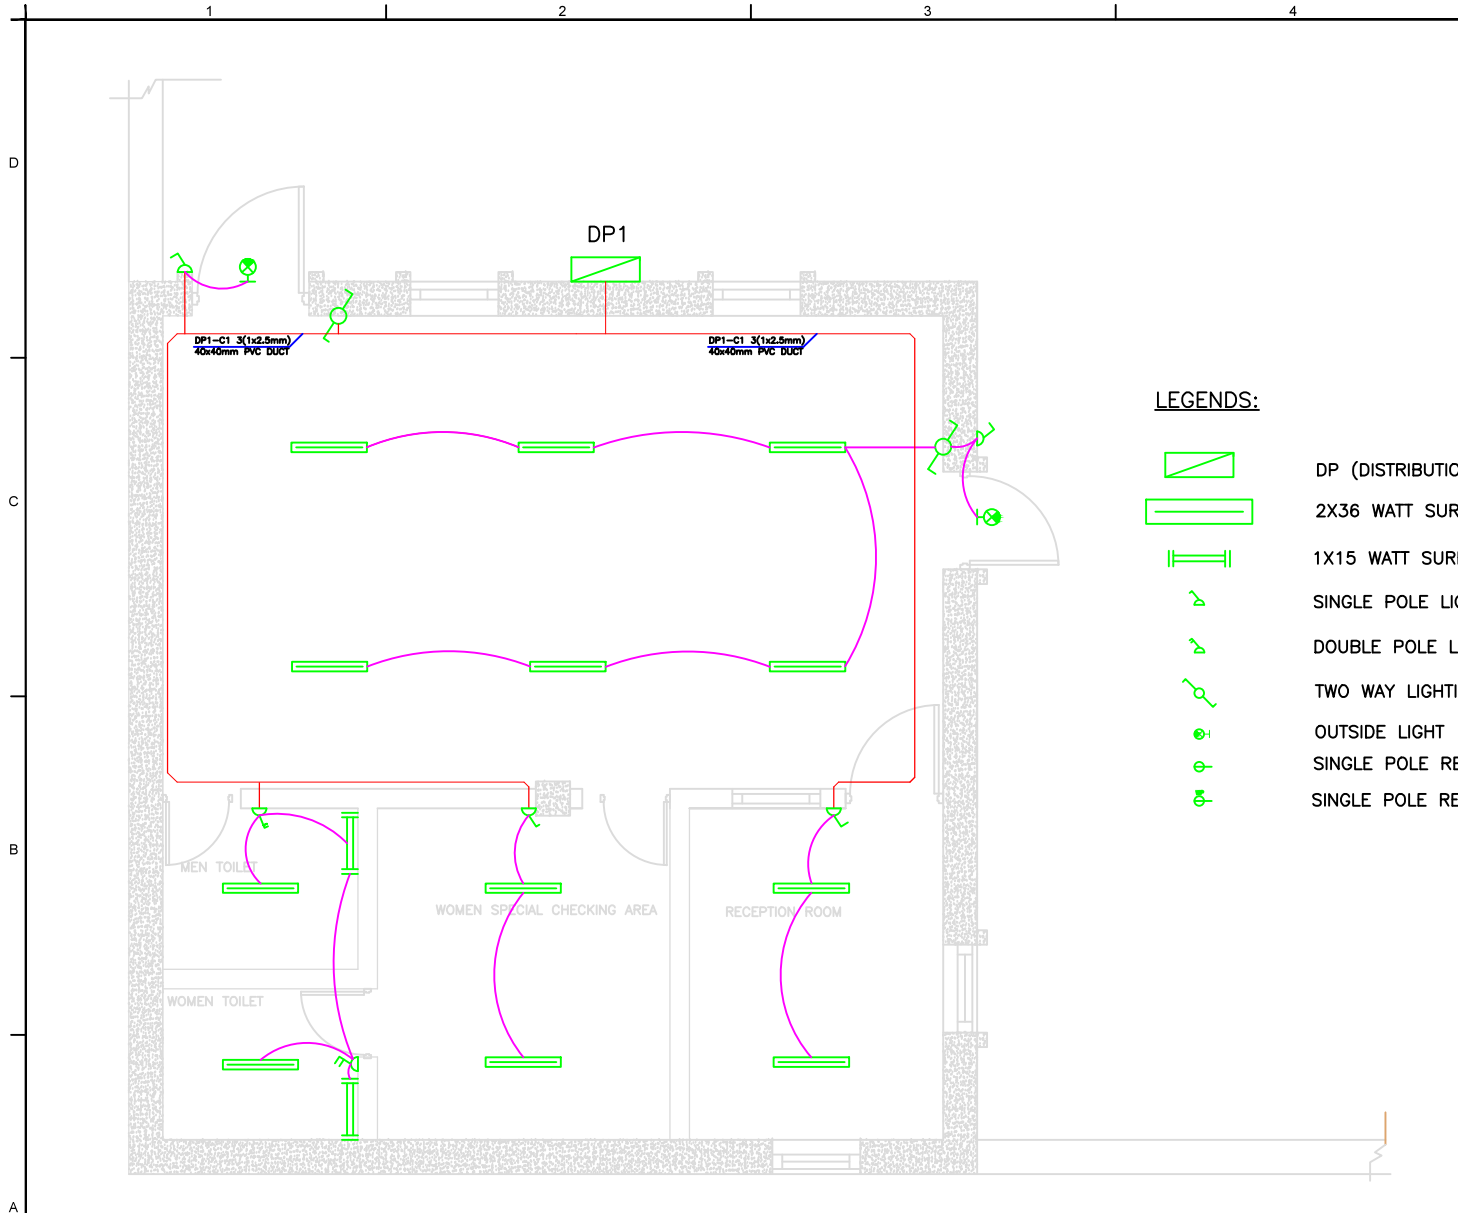

LEGENDS:


	DP (DISTRIBUTION PANEL BOARD)
	2X36 WATT SURFACE FLUORESCENT LIGHT FIXTURE
	1X15 WATT SURFACE FLUORESCENT MIRROR LIGHT WATER PROOF
	SINGLE POLE LIGHTING SWITCH
	DOUBLE POLE LIGHTING SWITCH
	TWO WAY LIGHTING SWITCH
	OUTSIDE LIGHT
	SINGLE POLE RECEPTACLE
	SINGLE POLE RECEPTACLE WATER PROOF

ISSUED FOR CONSTRUCTION


IMPLEMENTOR		UNITED NATIONS DEVELOPMENT PROGRAM		
PROJECT: CHECK POINT BUILDING				
DRAWING TITLE: Lighting Plan (DP1)				
DESIGNED:		PROJECT NO:	DRAWING NO. E01	REV. 0
DRAWN:		SHEET SIZE: A3		
CHECKED:		SCALE: 1:50		
APPROVED:		DATE:		

1 A.C.P Lighting Plan (DP1)
E-01 SCALE: 1:50

No	DATE	REVISION
0		ISSUED FOR TENDER PURPOSE ONLY
1		ISSUED FOR CONSTRUCTION
2		
3		

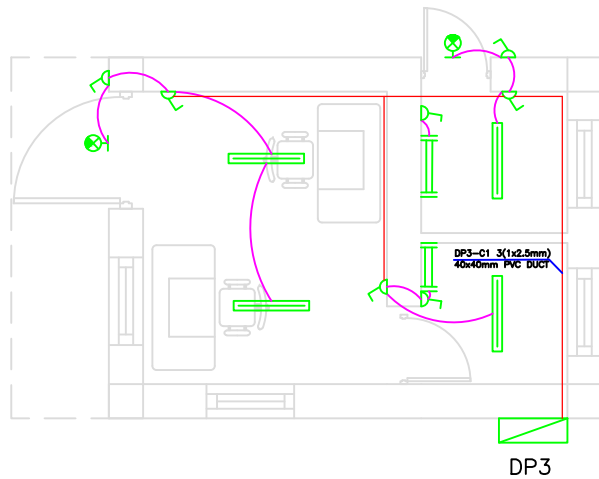

DP3

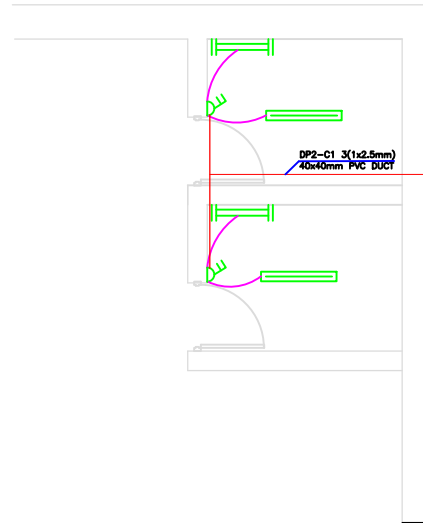

DP2

 
LEGENDS:



DP (DISTRIBUTION PANEL BOARD)



2X36 WATT SURFACE FLUORESCENT LIGHT FIXTURE



1X15 WATT SURFACE FLUORESCENT
MIRROR LIGHT WATER PROOF



SINGLE POLE LIGHTING SWITCH



DOUBLE POLE LIGHTING SWITCH



TWO WAY LIGHTING SWITCH



OUTSIDE LIGHT



SINGLE POLE RECEPTACLE



SINGLE POLE RECEPTACLE WATER PROOF


1 Check point Lighting Plan
E-02 SCALE: 1:50

2 Male and Female toilets Lighting Plan
E-02 SCALE: 1:50

ISSUED FOR CONSTRUCTION

IMPLEMENTOR			
UNITED NATIONS DEVELOPMENT PROGRAM			
PROJECT: CHECK POINT BUILDING			
DRAWING TITLE: Kabul South Gate Lighting Plan (DP2 & DP3)			
DESIGNED:	PROJECT NO:	DRAWING NO. E02	REV. 0
DRAWN:	SHEET SIZE: A3		
CHECKED:	SCALE: 1:50		
APPROVED:	DATE:		

No	DATE	REVISION
0		ISSUED FOR TENDER PURPOSE ONLY
1		ISSUED FOR CONSTRUCTION
2		
3		

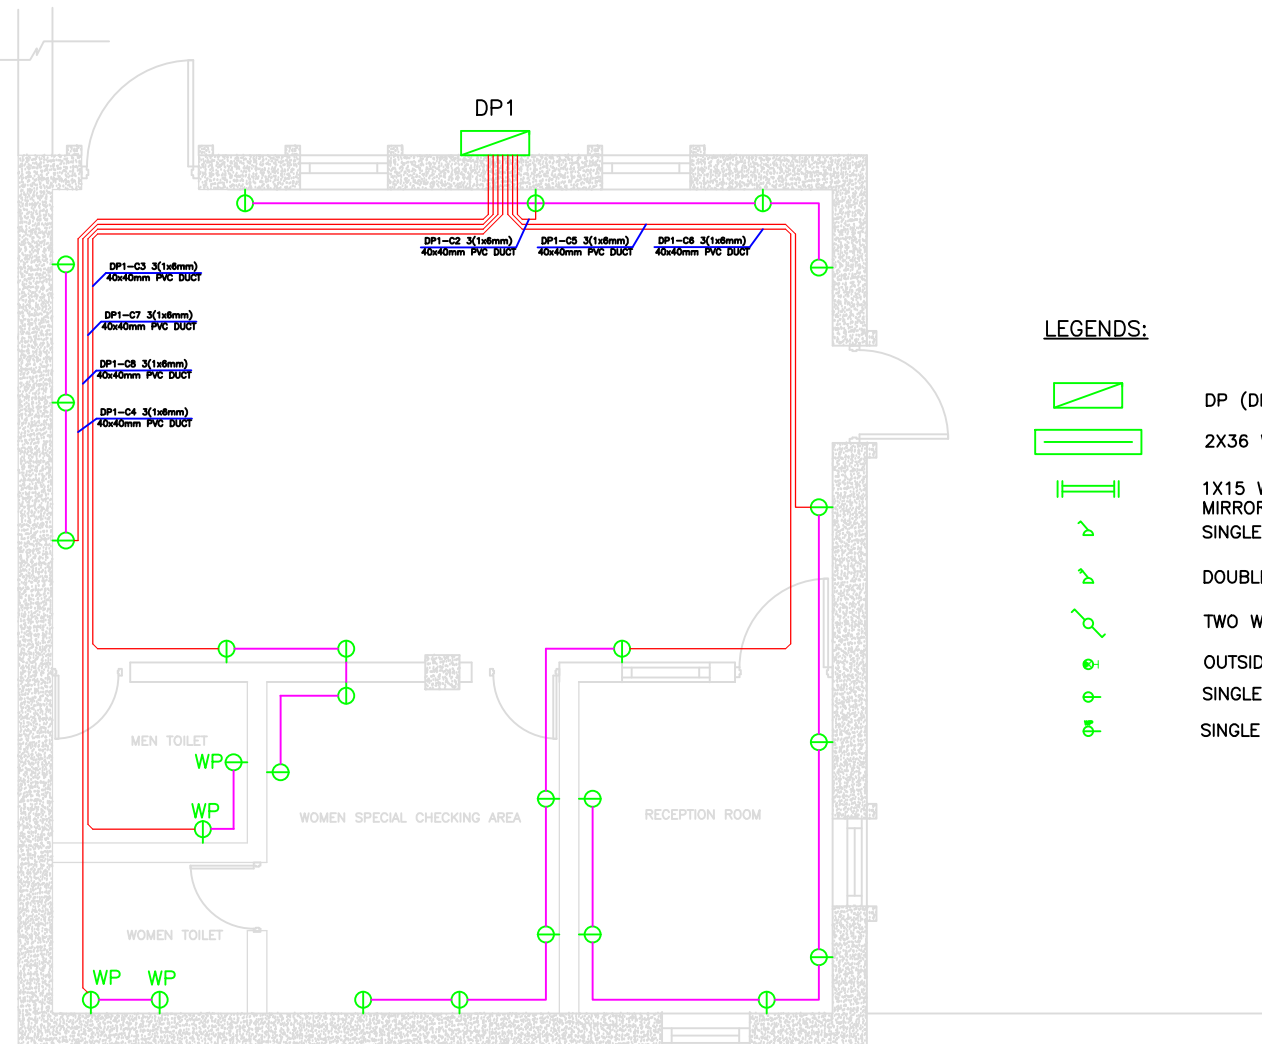


LEGENDS:

	DP (DISTRIBUTION PANEL BOARD)
	2X36 WATT SURFACE FLUORESCENT LIGHT FIXTURE
	1X15 WATT SURFACE FLUORESCENT MIRROR LIGHT WATER PROOF
	SINGLE POLE LIGHTING SWITCH
	DOUBLE POLE LIGHTING SWITCH
	TWO WAY LIGHTING SWITCH
	OUTSIDE LIGHT
	SINGLE POLE RECEPTACLE
	SINGLE POLE RECEPTACLE WATER PROOF

1
E-03 A.C.P Power Plan (DP1)
SCALE: 1:50

IMPLEMENTOR		UNITED NATIONS DEVELOPMENT PROGRAM		
PROJECT: CHECK POINT BUILDING				
DRAWING TITLE: Power Plan (DP1)				
DESIGNED:		PROJECT NO:	DRAWING NO. E03	REV. 0
DRAWN:		SHEET SIZE: A3		
CHECKED:		SCALE: 1:50		
APPROVED:		DATE:		

No	DATE	REVISION
0		ISSUED FOR TENDER PURPOSE ONLY
1		ISSUED FOR CONSTRUCTION
2		
3		

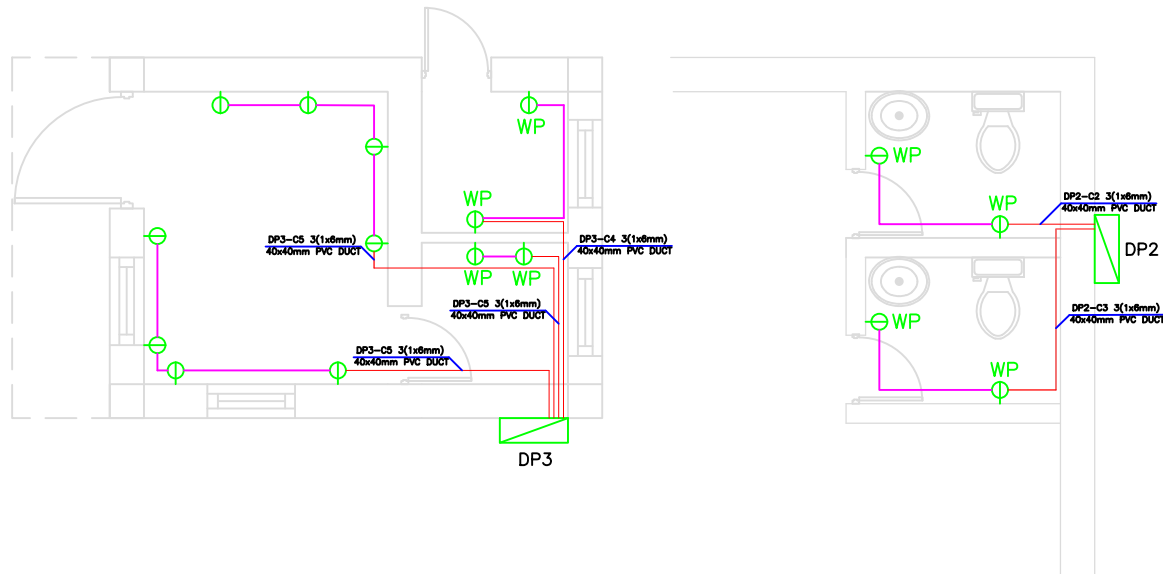


1 Check point Power Plan
E-04 SCALE: 1:100


2 Male and Female toilets Power Plan
E-04 SCALE: 1:100

IMPLEMENTOR		UNITED NATIONS DEVELOPMENT PROGRAM		
PROJECT: CHECK POINT BUILDING				
DRAWING TITLE: Power Plan (DP2 & DP3)				
DESIGNED:		PROJECT NO:	DRAWING NO. E04	REV. 0
DRAWN:		SHEET SIZE: A3		
CHECKED:		SCALE: 1:50		
APPROVED:		DATE:		


No	DATE	REVISION
0		ISSUED FOR TENDER PURPOSE ONLY
1		
2		
3		

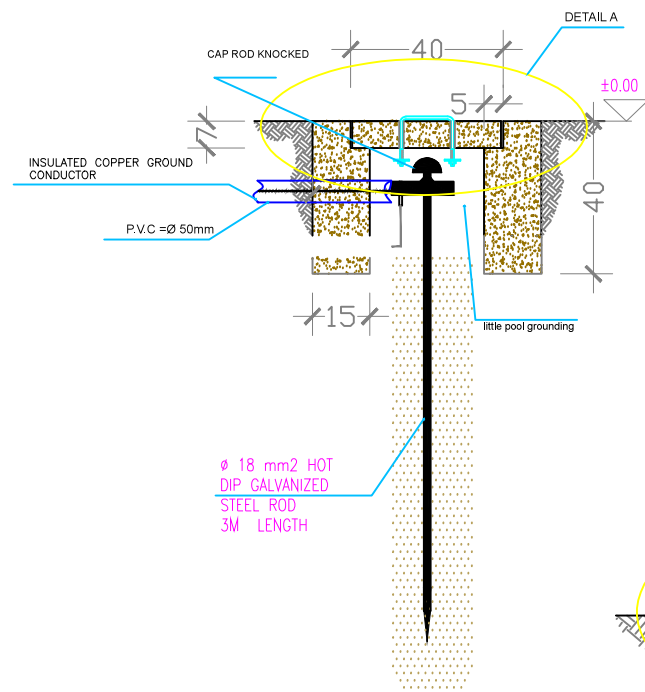

1
E-07
EARTHING SYSTEM PLAN DETAILS
Scale:NOT

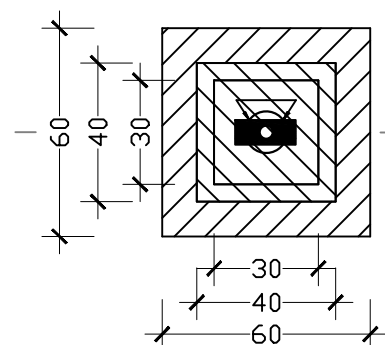

3
E-07
GROUNDING HAND HOLE DETAILS
Scale:NOT

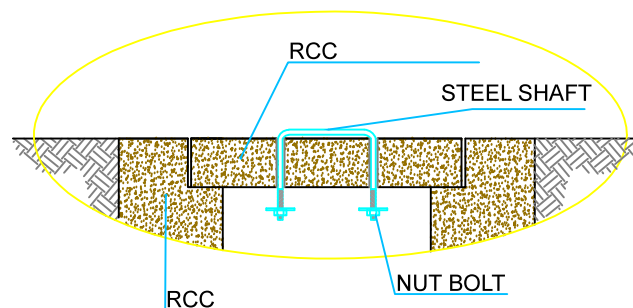

2
E-07
DETAILA
Scale:NOT

ISSUED FOR CONSTRUCTION

IMPLEMENTOR		UNITED NATIONS DEVELOPMENT PROGRAM	
PROJECT:			
CHECK POINT BUILDING			
DRAWING TITLE: EARTHING SYSTEM PLAN			
DESIGNED:		PROJECT NO:	
DRAWN:		SHEET SIZE:	A3
CHECKED:		SCALE:	1:05
APPROVED:		DATE:	
		DRAWING NO.	REV.
		E07	0