


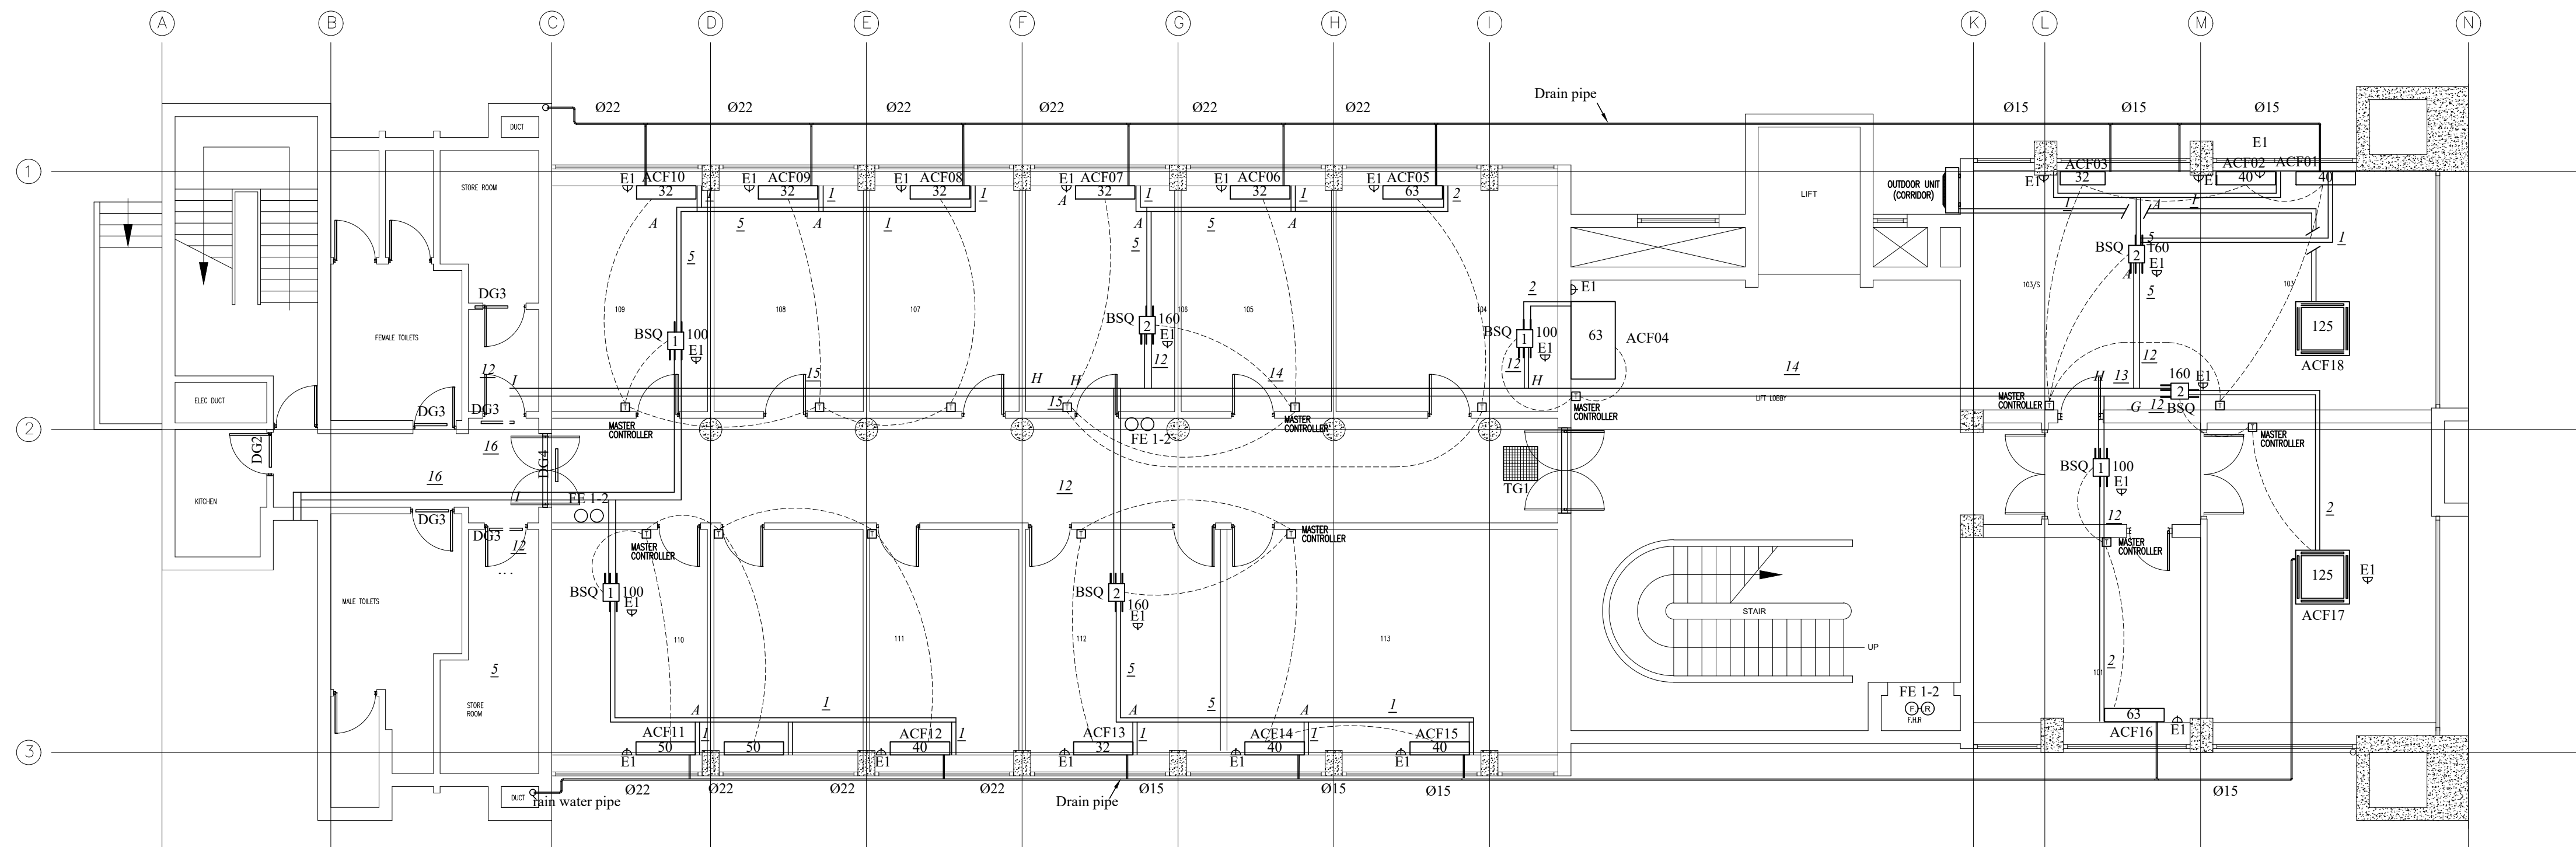

FIRST FLOOR PLAN

NOTES

REV.	DESCRIPTION	DATE

CLIENT

UN BOTSWANA

JOB TITLE

UNDP PROJECT

DRAWING TITLE


FIRST FLOOR – HVAC LAYOUT
EXISTING INSTALLATION

Architects:

A.R. EDWARDS & ASSOCIATES
CONSULTING PROJECT ENGINEERS
P.O. BOX 1468
GABORONE
BOTSWANA
TEL. 3912224
FAX 3973174
email: postmaster@area.co.bw

SCALE: 1:75	DATE: JAN. 2018
DRAWN: CDK	CHECKED: AM

DRAWING No.	REV.
ARE & A	1600-02-102
CLIENT	

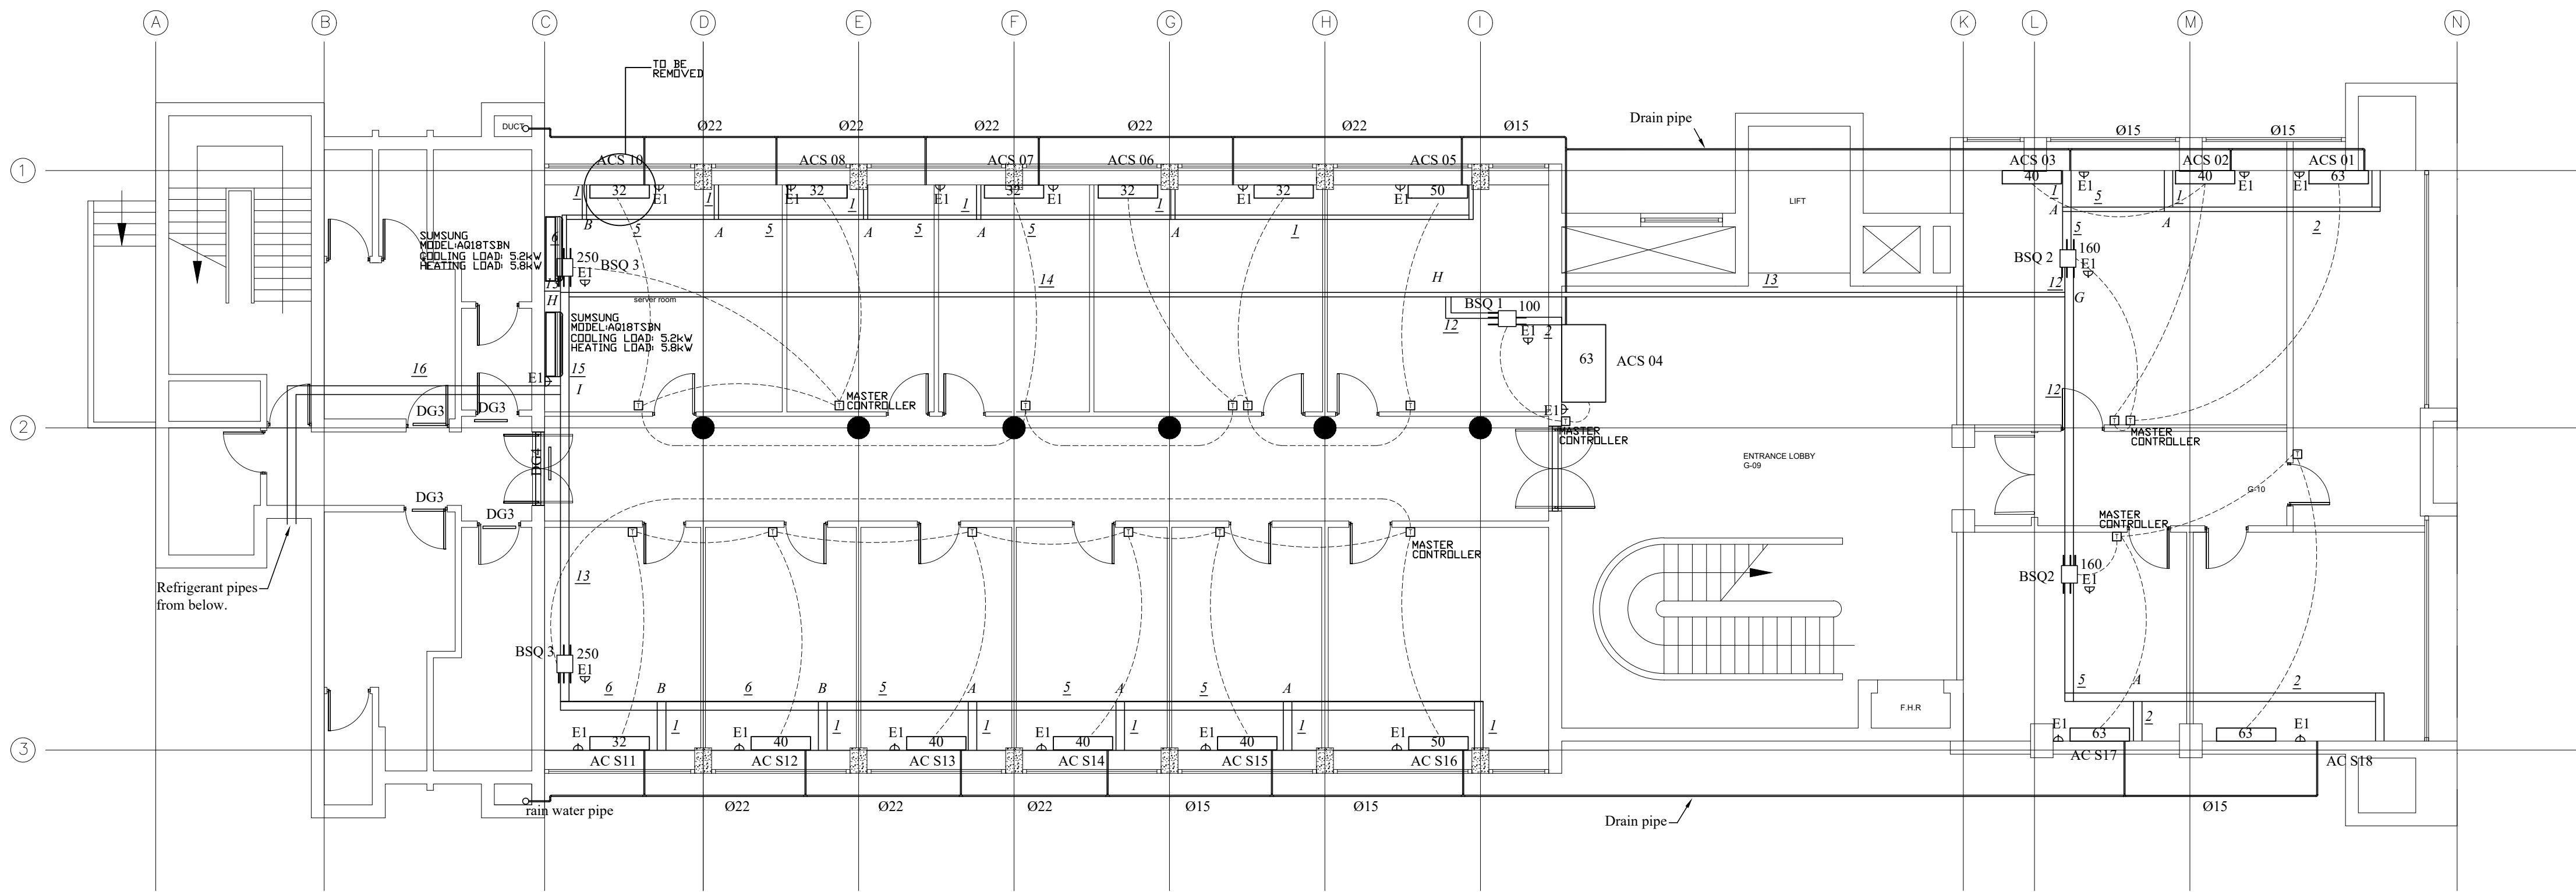

SECOND FLOOR PLAN

NOTES

REV.	DESCRIPTION	DATE

CLIENT

UN BOTSWANA

JOB TITLE

UNDP PROJECT

DRAWING TITLE


SECOND FLOOR – HVAC LAYOUT
EXISTING INSTALLATION

Architects:

A.R. EDWARDS & ASSOCIATES
CONSULTING PROJECT ENGINEERS
P.O. BOX 1468 GABORONE BOTSWANA
TEL. 3912224 FAX 3973174
email: postmaster@aea.co.bw


SCALE: 1:75	DATE: JAN. 2018
DRAWN: CDK	CHECKED: AM

DRAWING No.	REV.
ARE & A	1600-02-103
CLIENT	

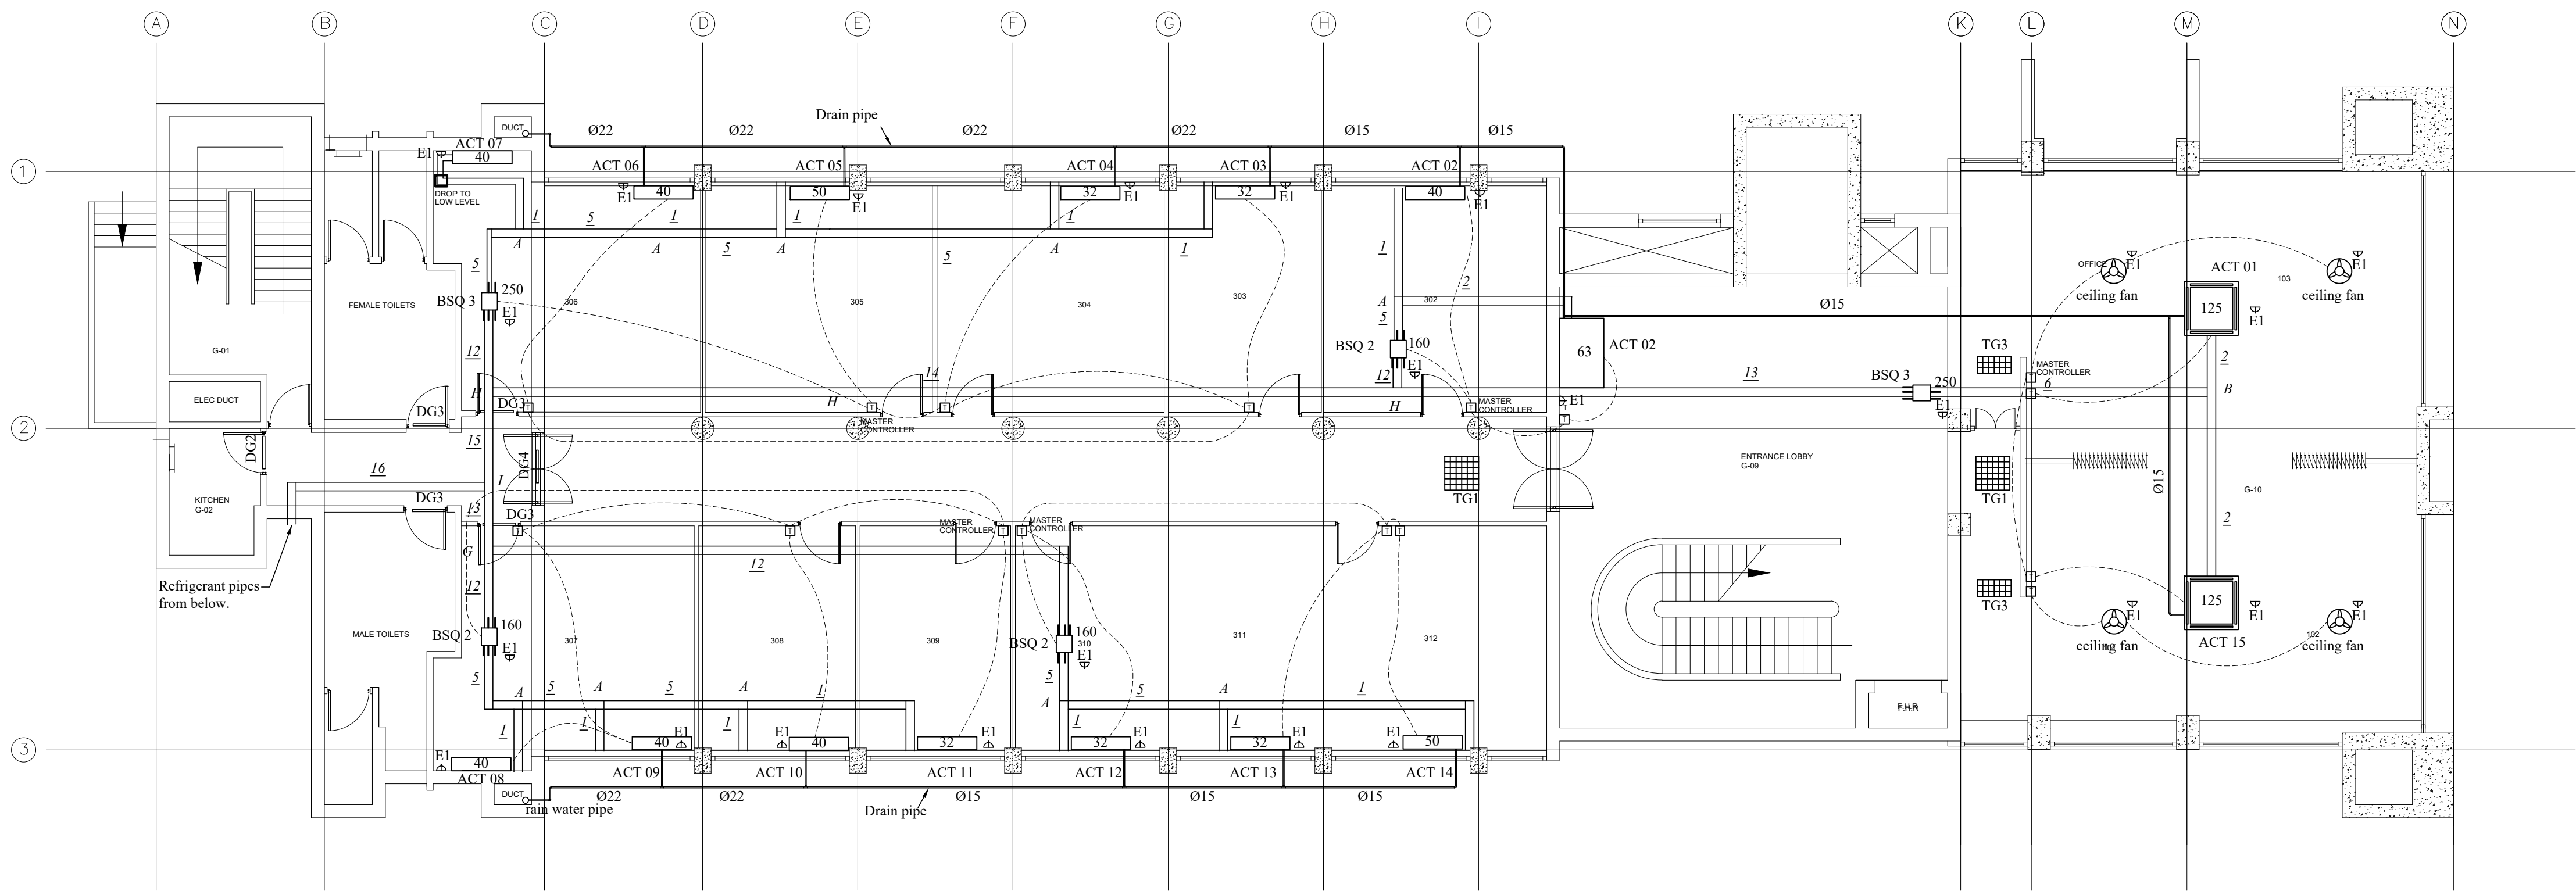

THIRD FLOOR PLAN

NOTES		
REV.	DESCRIPTION	DATE
CLIENT		
UN BOTSWANA		
JOB TITLE		
UNDP PROJECT		
DRAWING TITLE		
THIRD FLOOR – HVAC LAYOUT EXISTING INSTALLATION		
Architects:		
A.R. EDWARDS & ASSOCIATES CONSULTING PROJECT ENGINEERS		
P.O. BOX 1468 TEL. 3912224 GABORONE FAX 3973174 BOTSWANA email: postmaster@area.co.bw		
SCALE 1:75	DATE JAN. 2018	
DRAWN CDK	CHECKED AM	
DRAWING No.		REV.
ARE & A	1600-02-104	
CLIENT		

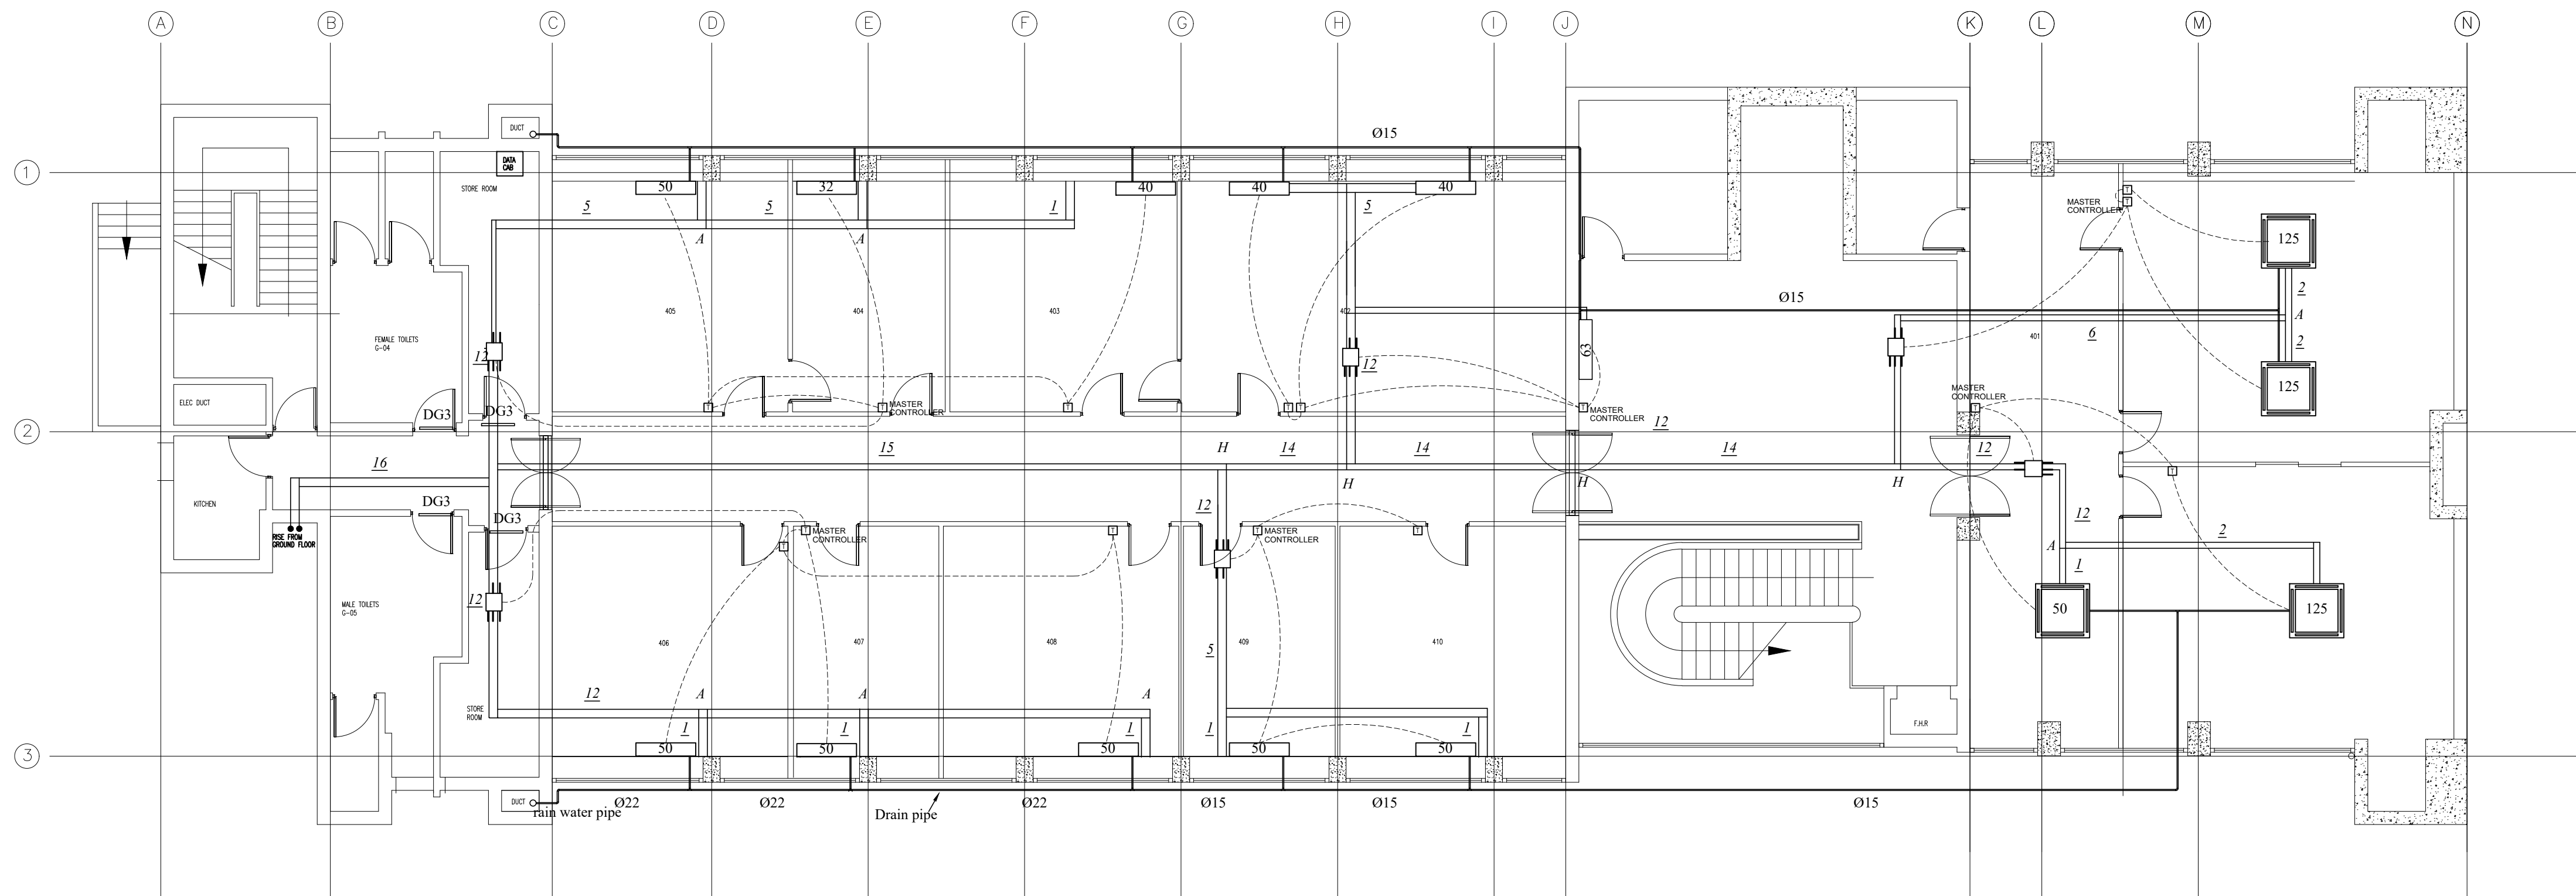

FOURTH FLOOR PLAN

NOTES

REV.	DESCRIPTION	DATE

CLIENT
UN BOTSWANA

JOB TITLE
UNDP PROJECT

DRAWING TITLE
**FOURTH FLOOR – HVAC LAYOUT
EXISTING INSTALLATION**

Architects:

A.R. EDWARDS & ASSOCIATES
CONSULTING PROJECT ENGINEERS
P.O. BOX 1468 GABORONE BOTSWANA
TEL. 3912224 FAX 3973174
email: postmaster@aea.co.bw

SCALE 1:75	DATE JAN. 2018
DRAWN CDK	CHECKED AM

DRAWING No.	REV.
ARE & A	1600-02-105
CLIENT	