


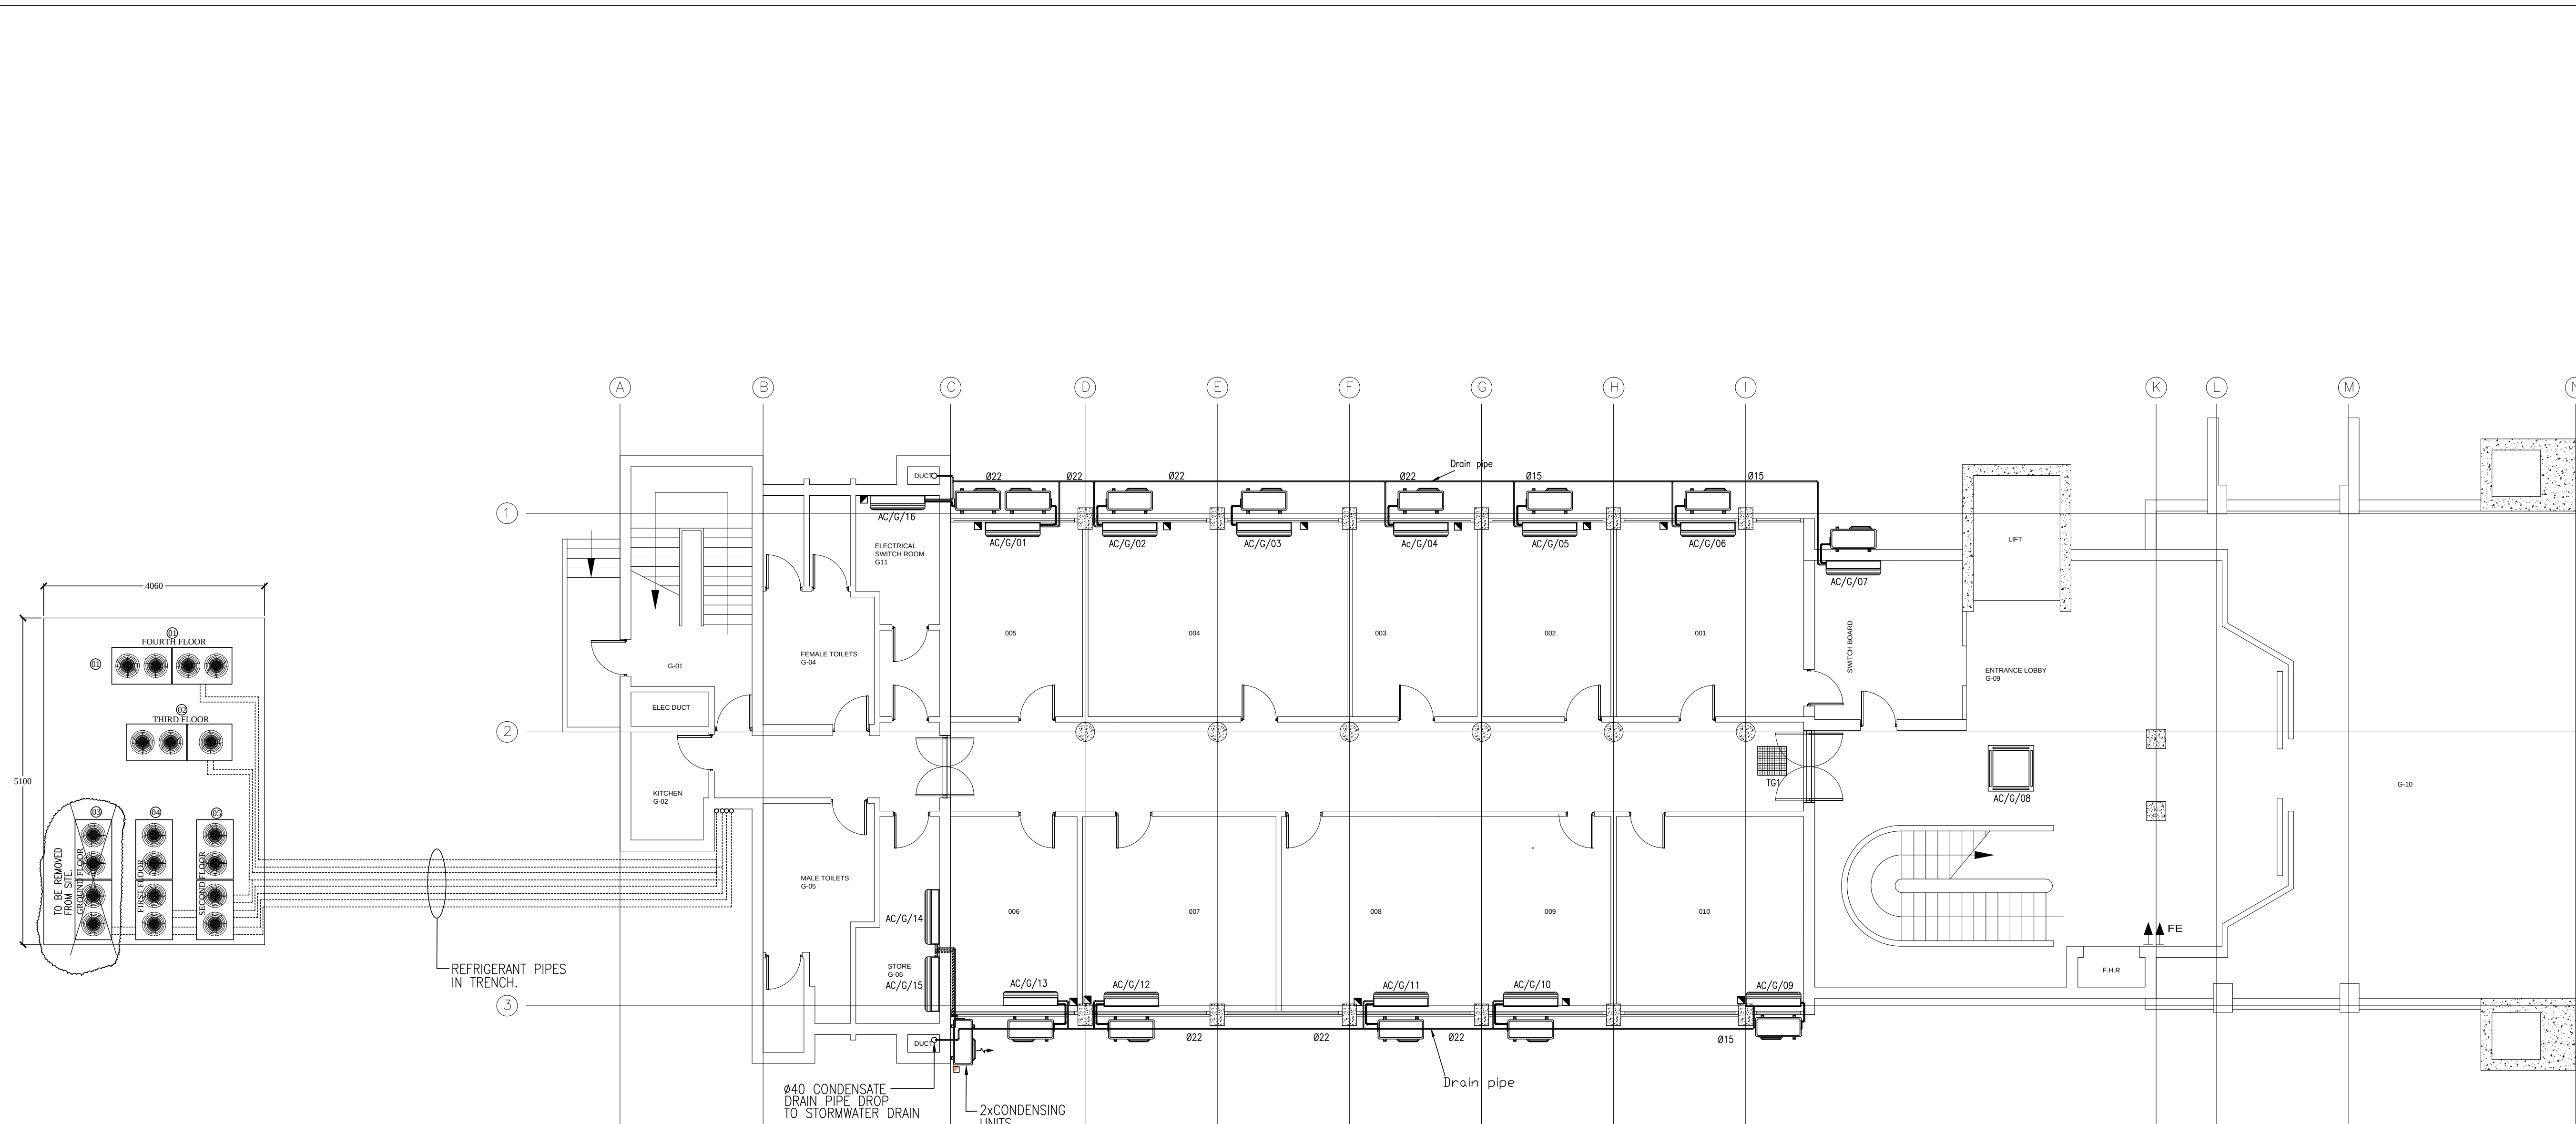

GROUND FLOOR PLAN

- GENERAL NOTES
1. THIS DRAWING SHALL BE READ IN CONJUNCTION WITH THE SPECIFICATION AND ALL DRAWINGS LISTED THERE IN AND WITH THE ARCHITECTURAL,CIVIL AND STRUCTURAL CONTRACT DRAWINGS.
 2. THE CONTRACTOR SHALL BE RESPONSIBLE FOR SETTING OUT CHECKING ALL DIMENSIONS ON SITE.
 3. NO DIMENSIONS ARE TO BE SCALED FROM THIS DRAWING. DIMENSIONS ARE TO VERIFIED ON SITE.
 - 4.THE CONTRACTOR IS TO CHECK THE DRAWING AND REPORT ANY DISCREPENCIES TO THE ENGINEER.

B	ISSUED FOR TENDER	01.08.18
A	ISSUED FOR TENDER	01.07.18
REV.	DESCRIPTION	DATE

CLIENT

UN BOTSWANA

JOB TITLE

UNDP PROJECT

DRAWING TITLE

GROUND FLOOR – HVAC LAYOUT
PROPOSED INSTALLATION

Architects:

A.R. EDWARDS & ASSOCIATES
CONSULTING PROJECT ENGINEERS


P.O. BOX 1468 GABORONE BOTSWANA

TEL. 3912224 FAX 3973174 email: postmaster@area.co.bw

SCALE 1:75	DATE JAN. 2018
DRAWN CDK	CHECKED AM

DRAWING No.	REV.
ARE & A	1600-02-106
CLIENT	B

- GENERAL NOTES
1. THIS DRAWING SHALL BE READ IN CONJUNCTION WITH THE SPECIFICATION AND ALL DRAWINGS LISTED THERE IN AND WITH THE ARCHITECTURAL,CIVIL AND STRUCTURAL CONTRACT DRAWINGS.
 2. THE CONTRACTOR SHALL BE RESPONSIBLE FOR SETTING OUT CHECKING ALL DIMENSIONS ON SITE.
 3. NO DIMENSIONS ARE TO BE SCALED FROM THIS DRAWING. DIMENSIONS ARE TO BE VERIFIED ON SITE.
 - 4.THE CONTRACTOR IS TO CHECK THE DRAWING AND REPORT ANY DISCREPENCIES TO THE ENGINEER.

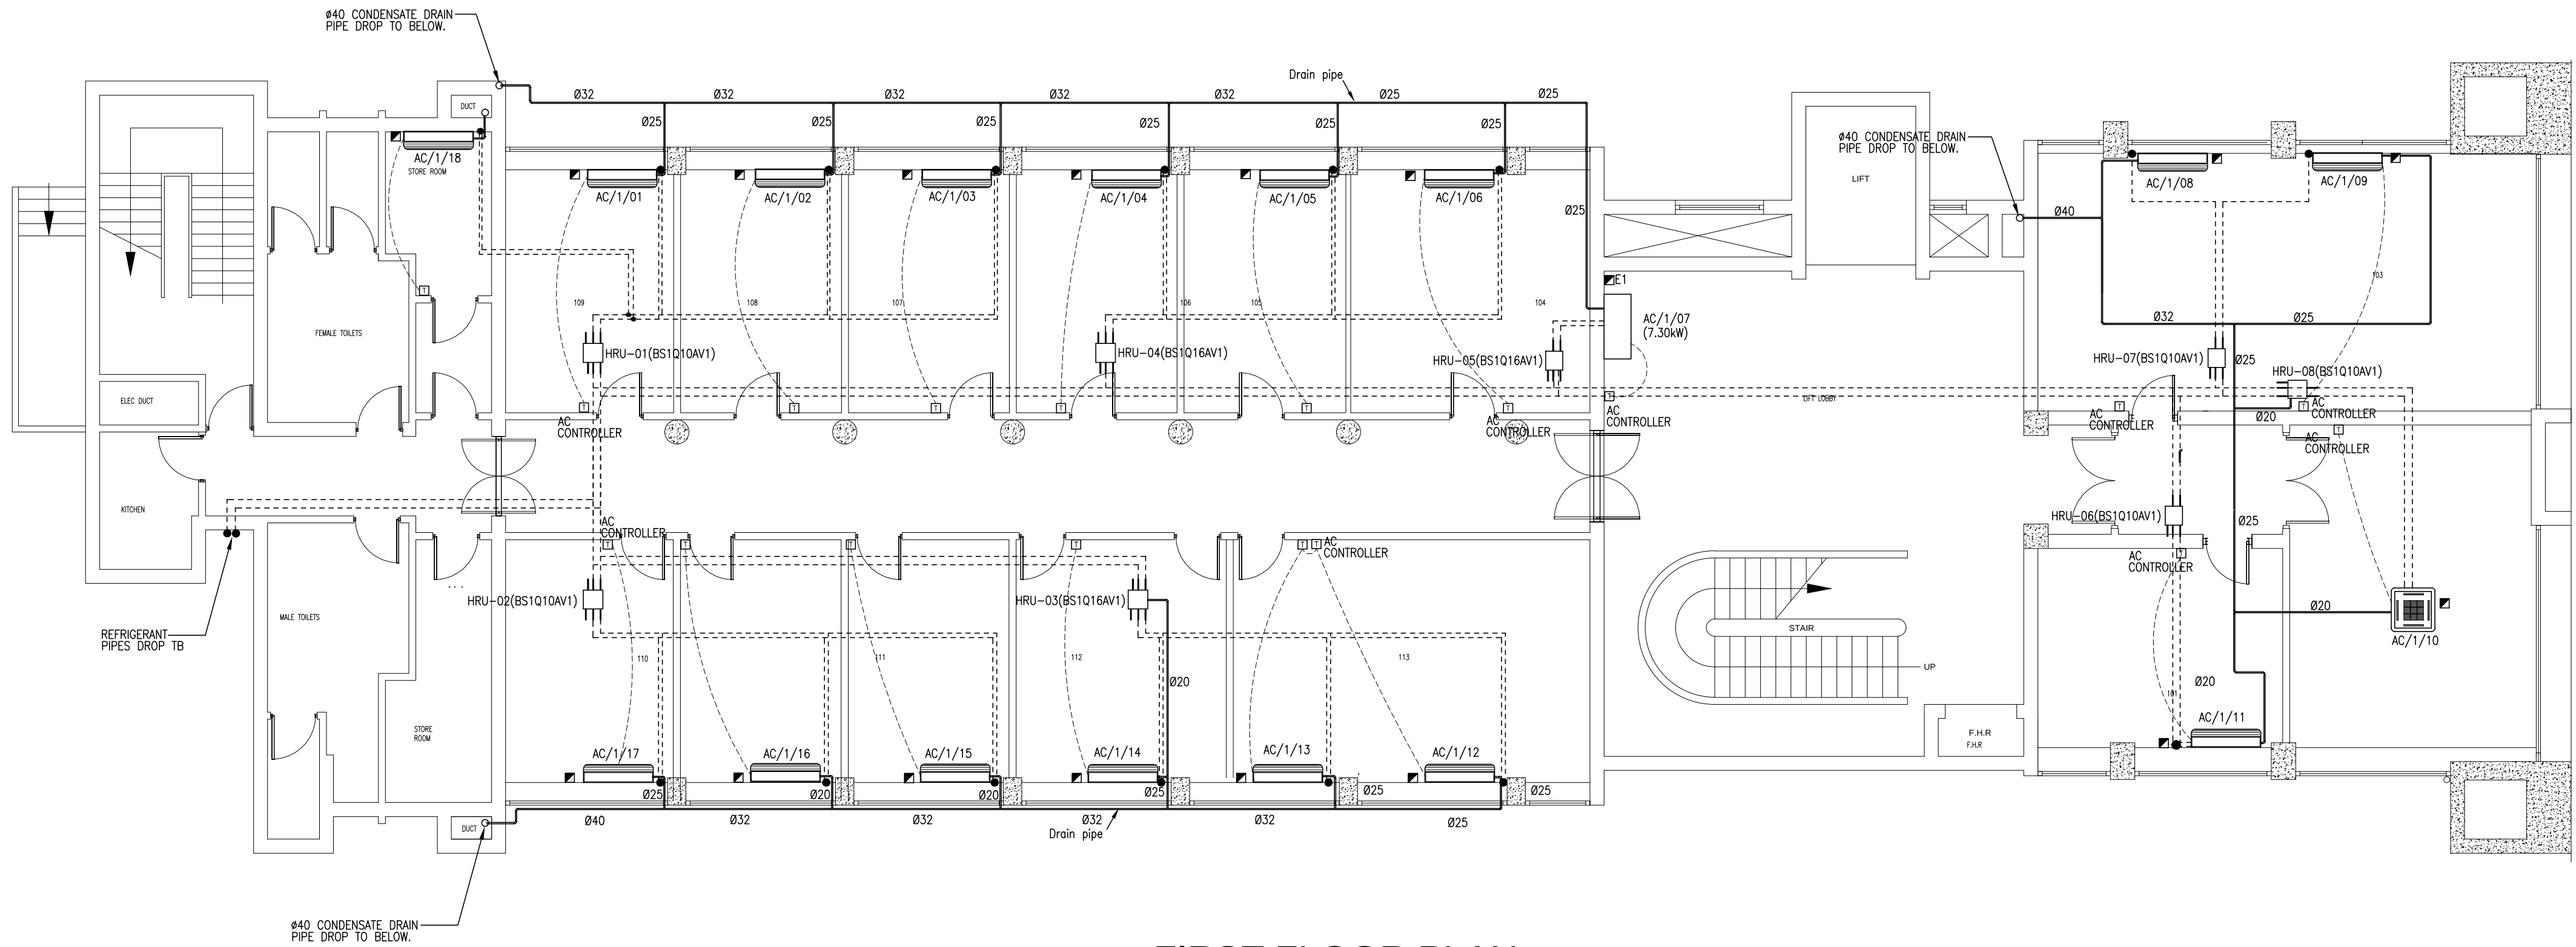

FIRST FLOOR PLAN

A	ISSUED FOR TENDER	01.08.18
A	ISSUED FOR TENDER	01.07.18
REV.	DESCRIPTION	DATE

CLIENT

UN BOTSWANA

JOB TITLE

UNDP PROJECT

DRAWING TITLE

FIRST FLOOR – HVAC LAYOUT
PROPOSED INSTALLATION

Architects:

A.R. EDWARDS & ASSOCIATES
CONSULTING PROJECT ENGINEERS

P.O. BOX 1468 TEL. 3912224
GABORONE FAX 3973174
BOTSWANA email: postmaster@area.co.bw

SCALE 1:75	DATE JAN. 2018
DRAWN CDK	CHECKED AM

DRAWING No.	REV.
ARE & A	1600-02-107
CLIENT	B

- | | | |
|------|-------------------|----------|
| | | |
| | | |
| | | |
| | | |
| | | |
| | | |
| B | ISSUED FOR TENDER | 01.08.18 |
| A | ISSUED FOR TENDER | 01.07.18 |
| REV. | DESCRIPTION | DATE |

UN BOTSWANA

UNDP PROJECT

SECOND FLOOR – HVAC LAYOUT
PROPOSED INSTALLATION

P.O. BOX 1468
GABORONE
BOTSWANA


TEL. 3912224
FAX 3973174
email: postmaster@area.co.bw

CHECKED AM

1



THIS DRAWING IS COPYRIGHT

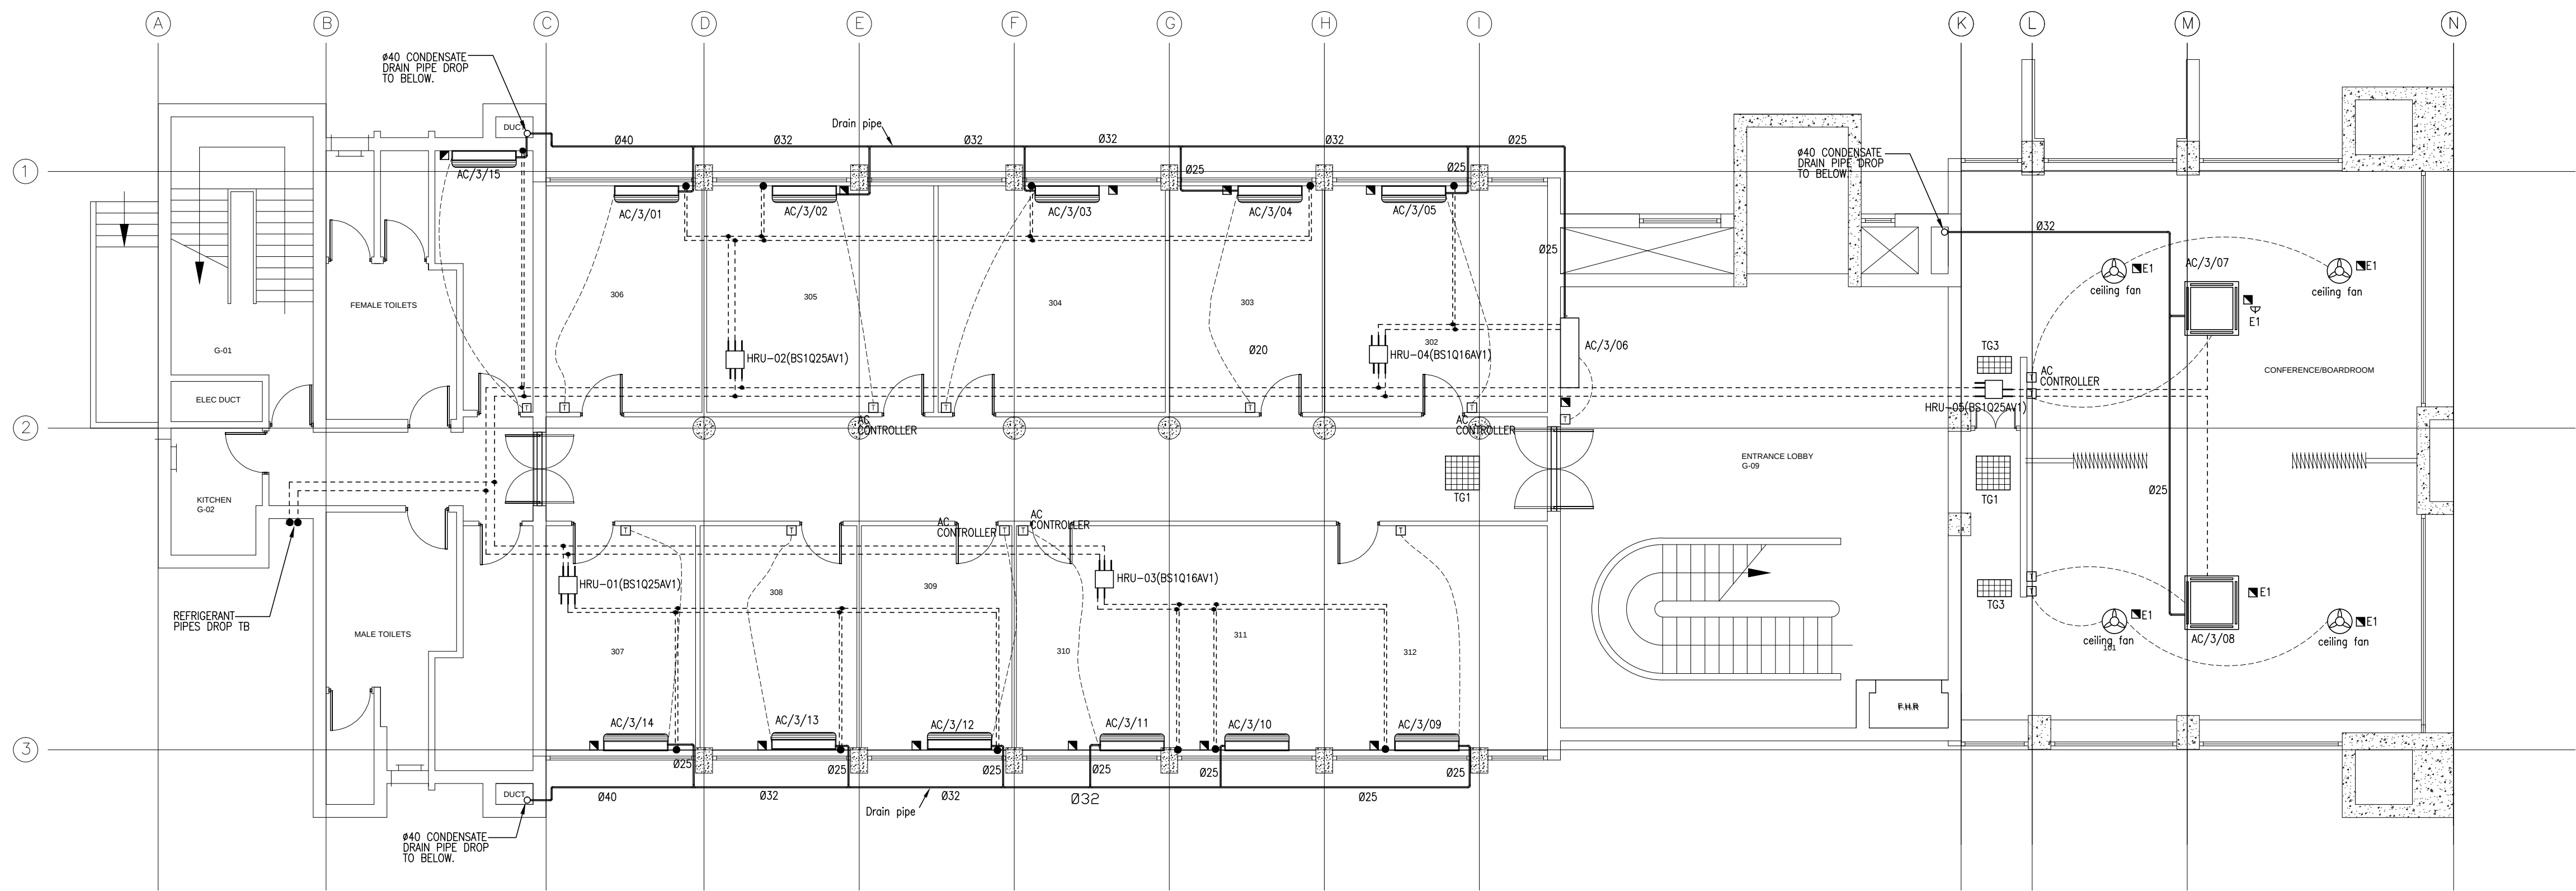

THIRD FLOOR PLAN

- GENERAL NOTES
1. THIS DRAWING SHALL BE READ IN CONJUNCTION WITH THE SPECIFICATION AND ALL DRAWINGS LISTED THERE IN AND WITH THE ARCHITECTURAL,CIVIL AND STRUCTURAL CONTRACT DRAWINGS.
 2. THE CONTRACTOR SHALL BE RESPONSIBLE FOR SETTING OUT CHECKING ALL DIMENSIONS ON SITE.
 3. NO DIMENSIONS ARE TO BE SCALED FROM THIS DRAWING. DIMENSIONS ARE TO VERIFIED ON SITE.
 - 4.THE CONTRACTOR IS TO CHECK THE DRAWING AND REPORT ANY DISCREPENCIES TO THE ENGINEER.

B	ISSUED FOR TENDER	01.08.18
A	ISSUED FOR TENDER	01.07.18
REV.	DESCRIPTION	DATE

CLIENT

UN BOTSWANA

JOB TITLE

UNDP PROJECT

DRAWING TITLE

THIRD FLOOR – HVAC LAYOUT
PROPOSED INSTALLATION

Architects:


A.R. EDWARDS & ASSOCIATES
CONSULTING PROJECT ENGINEERS

P.O. BOX 1468
GABORONE
BOTSWANA

TEL. 3912224
FAX 3973174
email: postmaster@area.co.bw

SCALE 1:75	DATE JAN. 2018
DRAWN CDK	CHECKED AM

DRAWING No.	REV.
ARE & A	1600–02–109
CLIENT	B

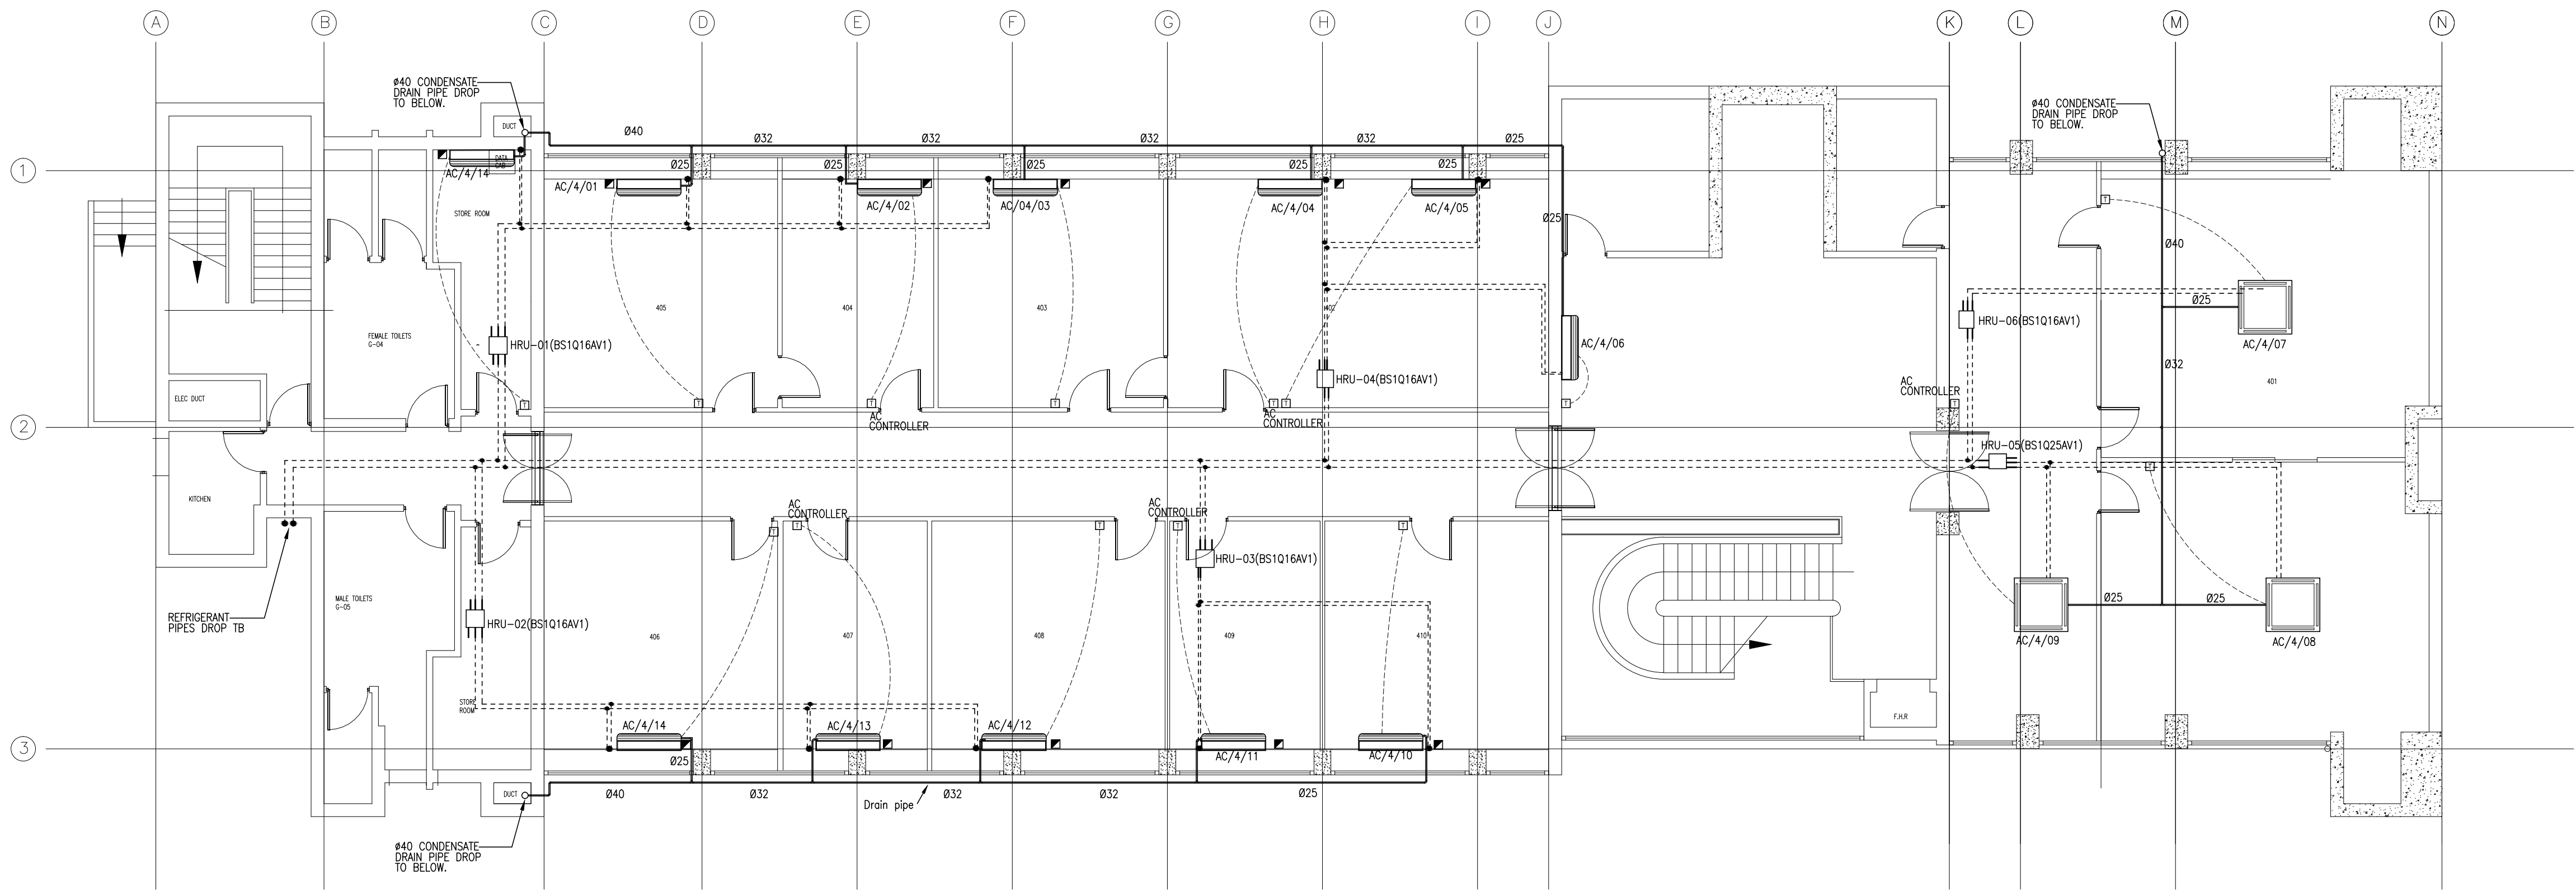

FOURTH FLOOR PLAN

- GENERAL NOTES
1. THIS DRAWING SHALL BE READ IN CONJUNCTION WITH THE SPECIFICATION AND ALL DRAWINGS LISTED THERE IN AND WITH THE ARCHITECTURAL,CIVIL AND STRUCTURAL CONTRACT DRAWINGS.
 2. THE CONTRACTOR SHALL BE RESPONSIBLE FOR SETTING OUT CHECKING ALL DIMENSIONS ON SITE.
 3. NO DIMENSIONS ARE TO BE SCALED FROM THIS DRAWING. DIMENSIONS ARE TO VERIFIED ON SITE.
 - 4.THE CONTRACTOR IS TO CHECK THE DRAWING AND REPORT ANY DISCREPENCIES TO THE ENGINEER.

B	ISSUED FOR TENDER	01.08.18
A	ISSUED FOR TENDER	01.07.18
REV.	DESCRIPTION	DATE

CLIENT

UN BOTSWANA

JOB TITLE

UNDP PROJECT

DRAWING TITLE

FOURTH FLOOR – HVAC LAYOUT
PROPOSED INSTALLATION

Architects:

A.R. EDWARDS & ASSOCIATES
CONSULTING PROJECT ENGINEERS

P.O. BOX 1468
GABORONE
BOTSWANA

TEL. 3912224
FAX 3973174
email: postmaster@area.co.bw

SCALE 1:75	DATE JAN. 2018
DRAWN CDK	CHECKED AM

DRAWING No.	REV.
ARE & A	1600-02-110
CLIENT	B