 
 
 
 
 
 

 
 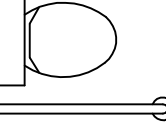
 
 
 



SYMBOLS LEGEND

ITEM	SYMBOL	ITEM	SYMBOL	ITEM	SYMBOL	ITEM	SYMBOL
	Ø 4" UPVC drainage pipe (1% Slope)		ELECTRICAL BOILER		SUPPLY SQUARE CEILING DIFUSER		
	Ø 2" UPVC drainage pipe (1% Slope)	T/B	TO BELOW		RETURN SQUARE CEILING GRILL		
	Ø 4" UPVC drainage pipe	F/B	FROM BELOW		RETURN SQUARE GRILL		
	Ø 4" Floor trap	T/A	TO ABOVE	G.S.P	GALVANIZED STEEL PIPE		
	4/2" Junction box	F/A	FROM ABOVE	D/D	DROP DOWN		
	4" Clean out	U/G	UNDER GROUND		WALL MOUNTED EXHAUST FAN		
	Ø 4" UPVC rain water pipe	U/T	UNDER TILE		FRESH AIR GRILL		
V.P	Ø 4" UPVC Vent pipe	U/C	UNDER CEILING		GAS CABINAT		
	4" Rain water drain	H/L	HIGH LEVEL		WESTERN W.C		
	Precast Circular Concrete Manhole		EXHAUST FAN		HANDICAPPED W.C		
	Flow Pipe (Heating)		Non Return Valve (Check Valve)		LAVATORY		
	Return Pipe (Heating)		Pressure Gauge		NON RETERN VALVE		
	Domestic Cold Water Supply		Pressure Switch		PUMP		
	Domestic Hot Water Supply		Automatic Air Vent		FIRE CABINET 120X80X30cm		
	Domestic Hot Water Return		5 Kg CO2 PORTABLE FIRE EXTIGUISHER		EXHAUST GRILL		
	Main Water supply		9 Kg DRY POWDER FIRE EXTIGUISHER				
	Fire Line		WATER COLLECTOR				
	Gas Line		EXHAUST CEILING GRILL				
	Fuel Supply		RETURN SQUARE GRILL				
	Fuel Return		RETURN AIR GRILL				



G.		
F.		
E.		
C.	THIRD REVISION	29/8/2018
B.	SECOND REVISION	7/8/2018
A.	FIRST REVISION	24/7/2018
Rev. No.	Rev. Description	Date

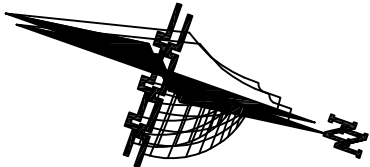

PIEFZA



UNDP




AL AMEED
Architects & Engineers
NABLUS Tel. 09-2340472 / 2340610 Fax.09-2341302 P.o.Box 1112

PROJECT TITLE
Construction of Two Additional Floors to the Administration
Building at Jericho Agro-Industrial Park
JERICHO

DRAWING Title

MECHANICAL SYMBOLS LEGEND

ARCHITECTURAL : NAHEEL YOUNES		
DRAWN : RANA HINDIA		
CHECKED : RAMI MALHIS		
APPROVED : RAMI MALHIS		
SCALE 1:100	DATE 9/ 2018	DRAWING NO. M-0

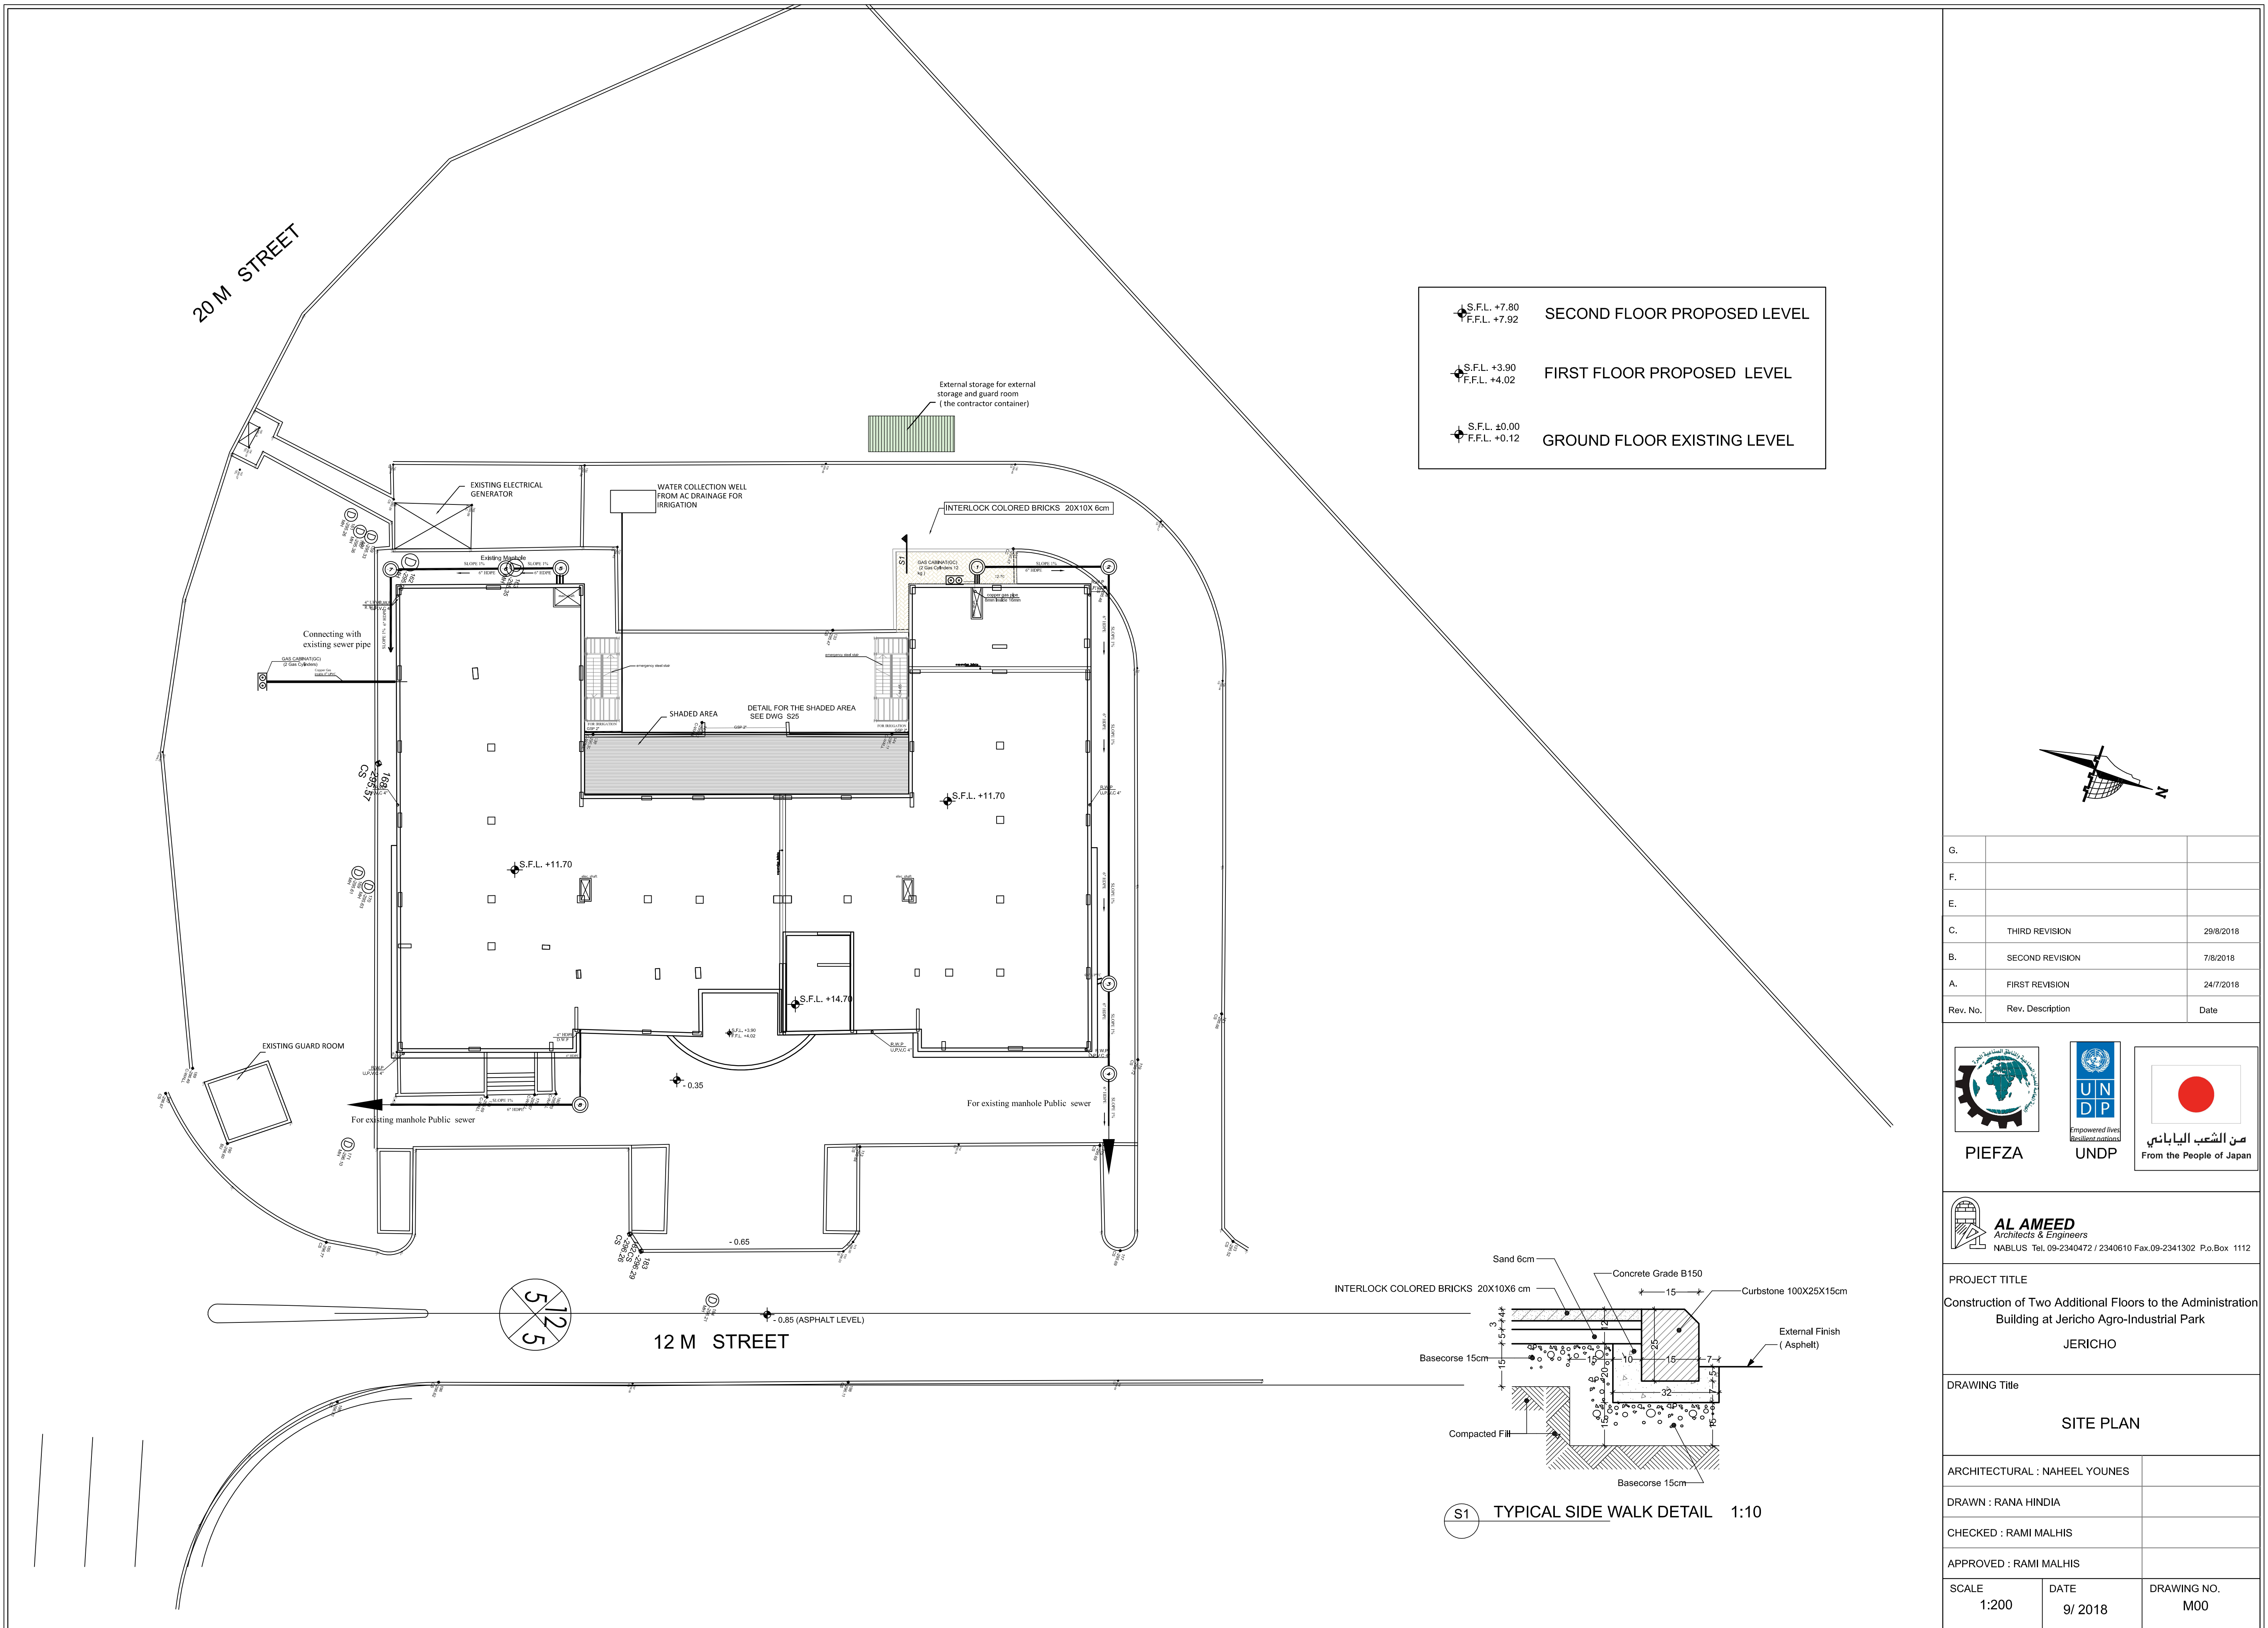


G.		
F.		
E.		
C.	THIRD REVISION	29/8/2018
B.	SECOND REVISION	7/8/2018
A.	FIRST REVISION	24/7/2018
Rev. No.	Rev. Description	Date




PIEFZA



UNDP

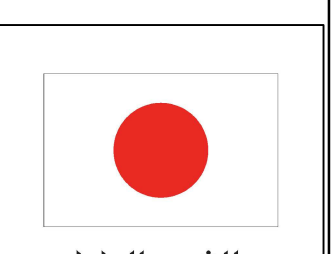

من الشعب الياباني
From the People of Japan

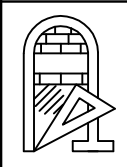

AL AMEED
Architects & Engineers
NABLUS Tel. 09-2340472 / 2340610 Fax.09-2341302 P.o.Box 1112

PROJECT TITLE
Construction of Two Additional Floors to the Administration
Building at Jericho Agro-Industrial Park
JERICHO


DRAWING Title

SITE PLAN

ARCHITECTURAL : NAHEEL YOUNES	
DRAWN : RANA HINDIA	
CHECKED : RAMI MALHIS	
APPROVED : RAMI MALHIS	
SCALE 1:200	DATE 9/ 2018
	DRAWING NO. M00

LEGEND:

- 7 • SEWAGE MANHOLE
- Ø6" U.P.V.C DRAIN PIPE
- Ø4" U.P.V.C DRAIN SUSPENDED PIPE
- Ø4" U.P.V.C DRAIN PIPE-U.T
- Ø2" U.P.V.C DRAIN PIPE-U.T
- 4" FLOOR TRAP
- 4" FLOOR CLEAN OUT
- ROOF DRAIN
- Ø4" UPVC DRAIN & VENT RISER
- SUSPENDE CLEAN OUT
- T/A TO ABOVE
- F/A FROM ABOVE
- U.T UNDER TILES
- SINK
- WESTERN W.C
- HANDICAPPED W.C
- LAVATORY
- WATER COOLER
- WATER GRILL

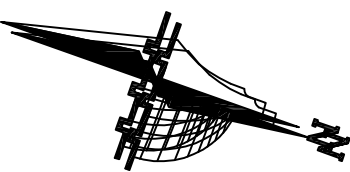

G.		
F.		
E.		
C.	THIRD REVISION	29/8/2018
B.	SECOND REVISION	7/8/2018
A.	FIRST REVISION	24/7/2018
Rev. No.	Rev. Description	Date





AL AMEED
Architects & Engineers
NABLUS Tel. 09-2340472 / 2340610 Fax.09-2341302 P.o.Box 1112

PROJECT TITLE
Construction of Two Additional Floors to the Administration
Building at Jericho Agro-Industrial Park
JERICHO


DRAWING Title
GROUND FLOOR PLAN
DRAINAGE SYSTEM

ARCHITECTURAL : NAHEEL YOUNES	
DRAWN : RANA HINDIA	
CHECKED : RAMI MALHIS	
APPROVED : RAMI MALHIS	
SCALE 1:100	DATE 9/ 2018
DRAWING NO. M-100	

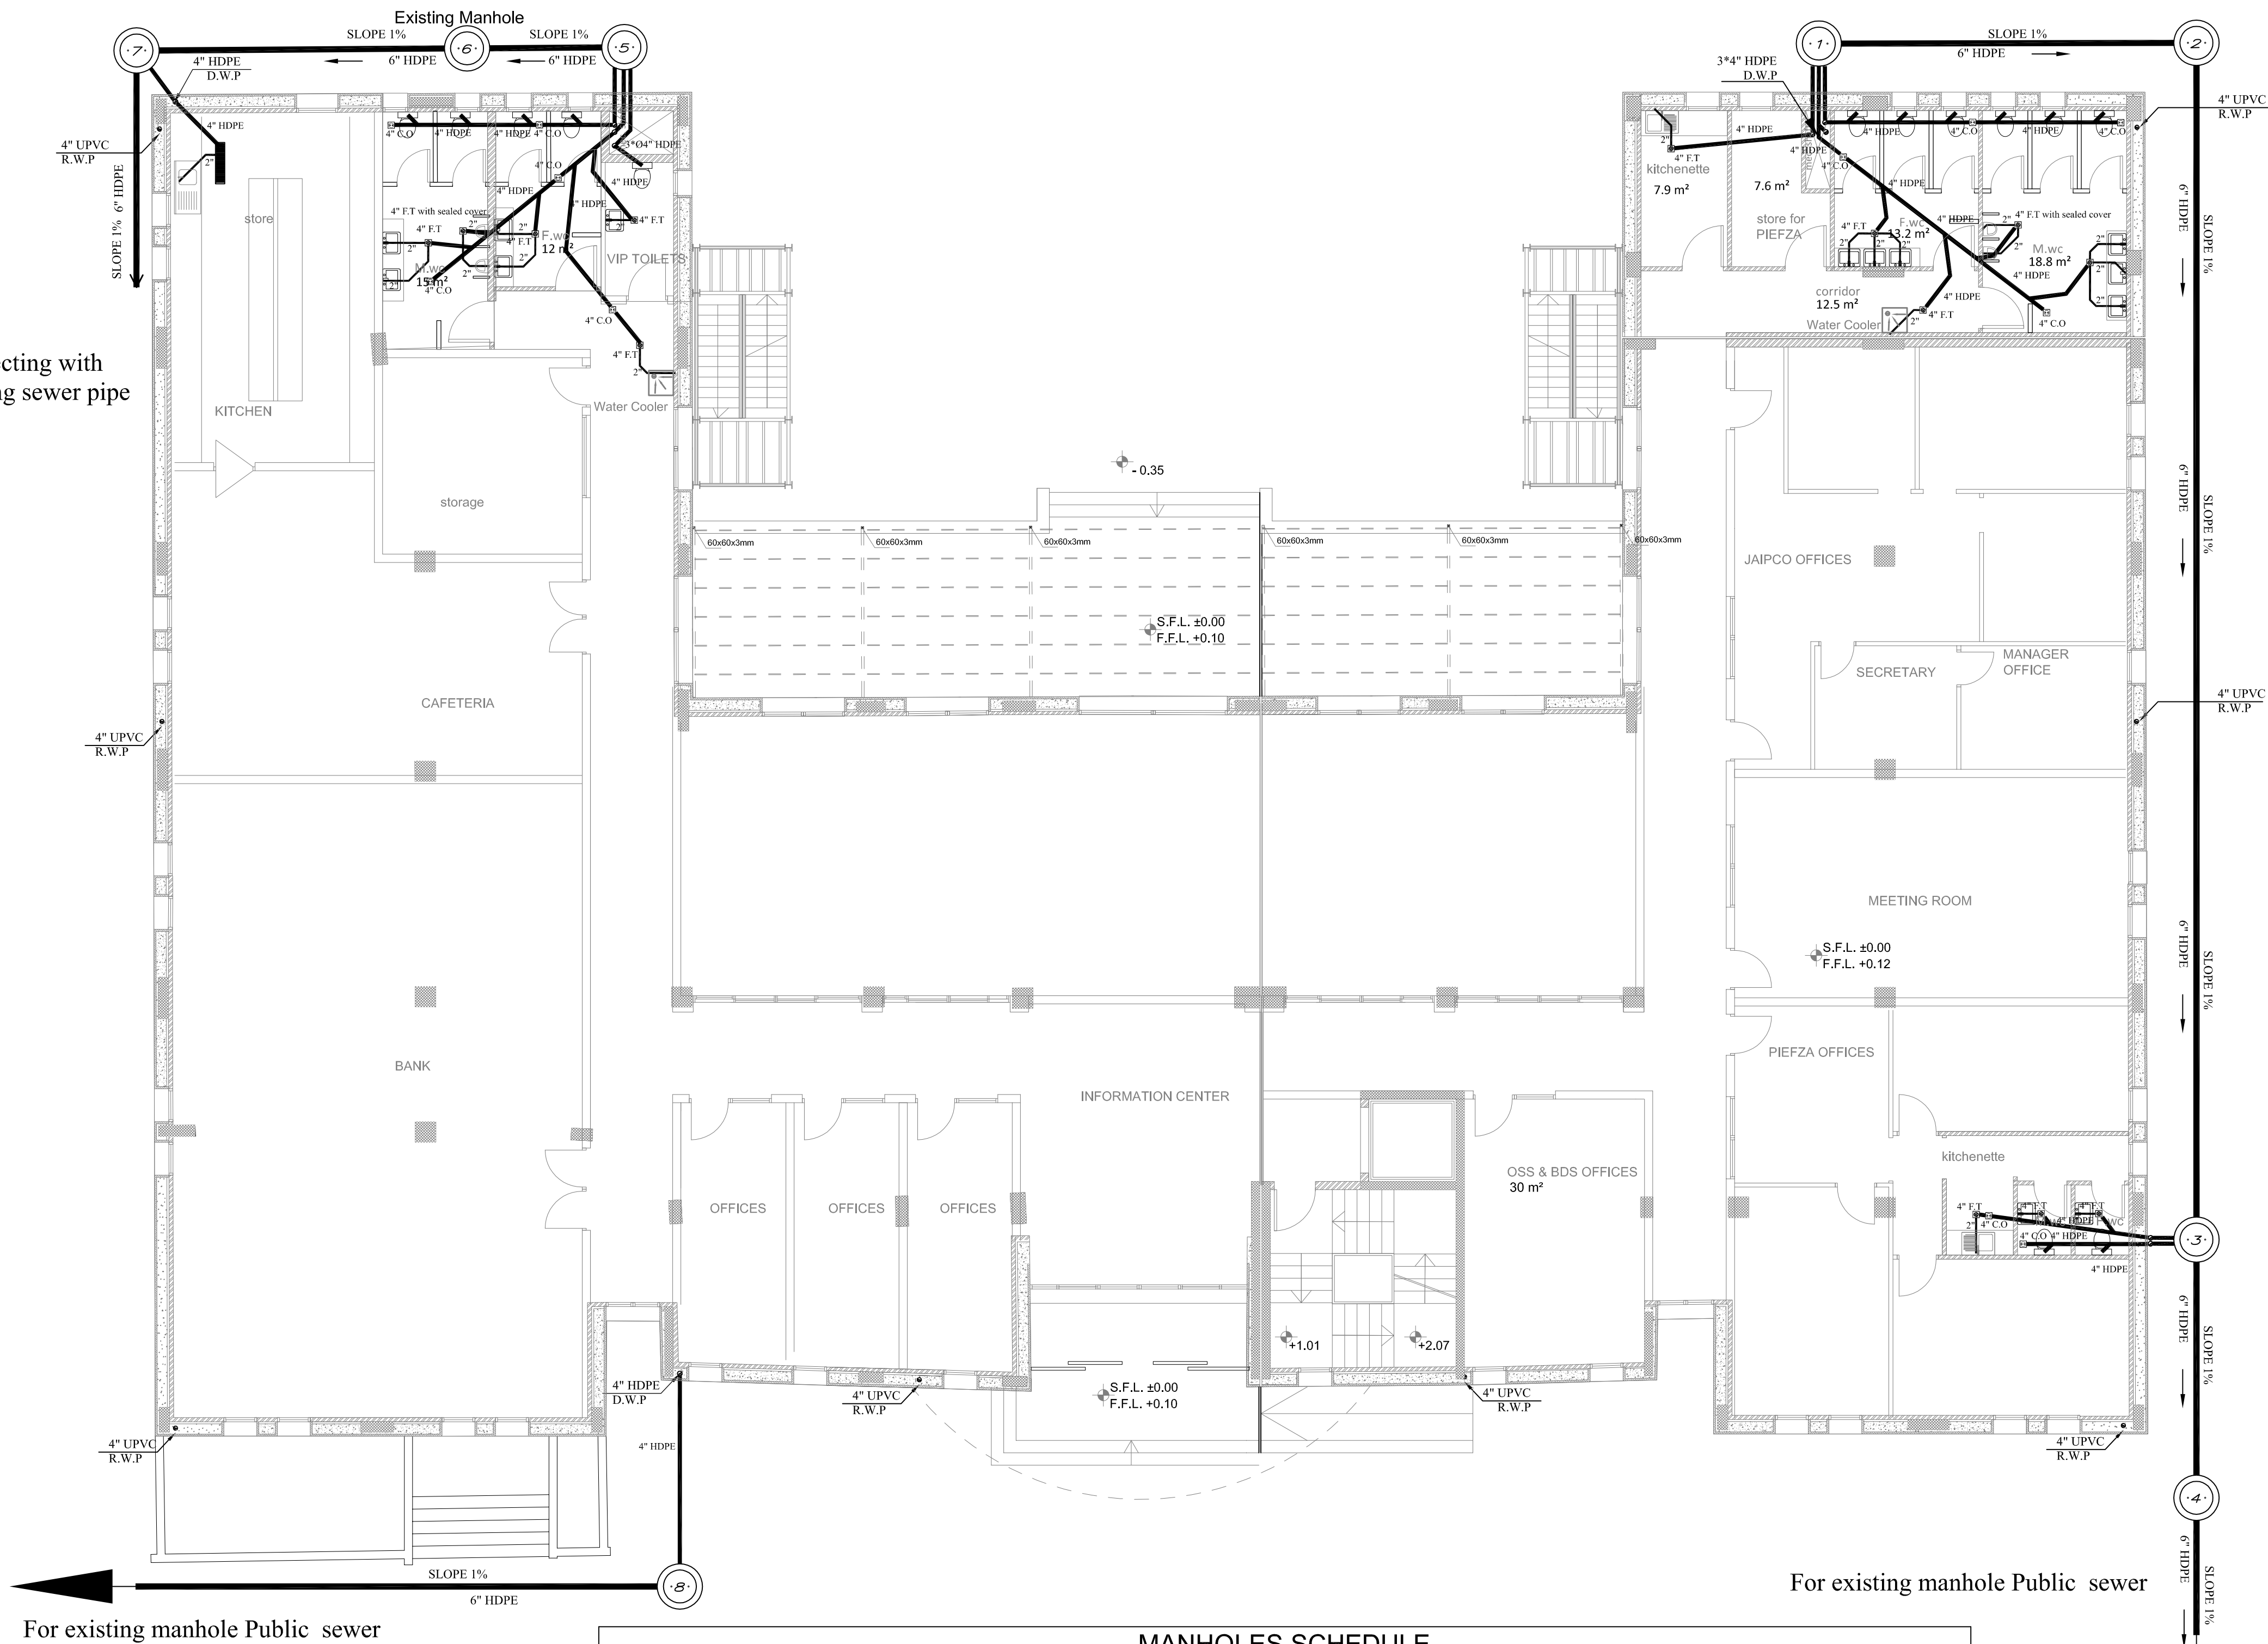


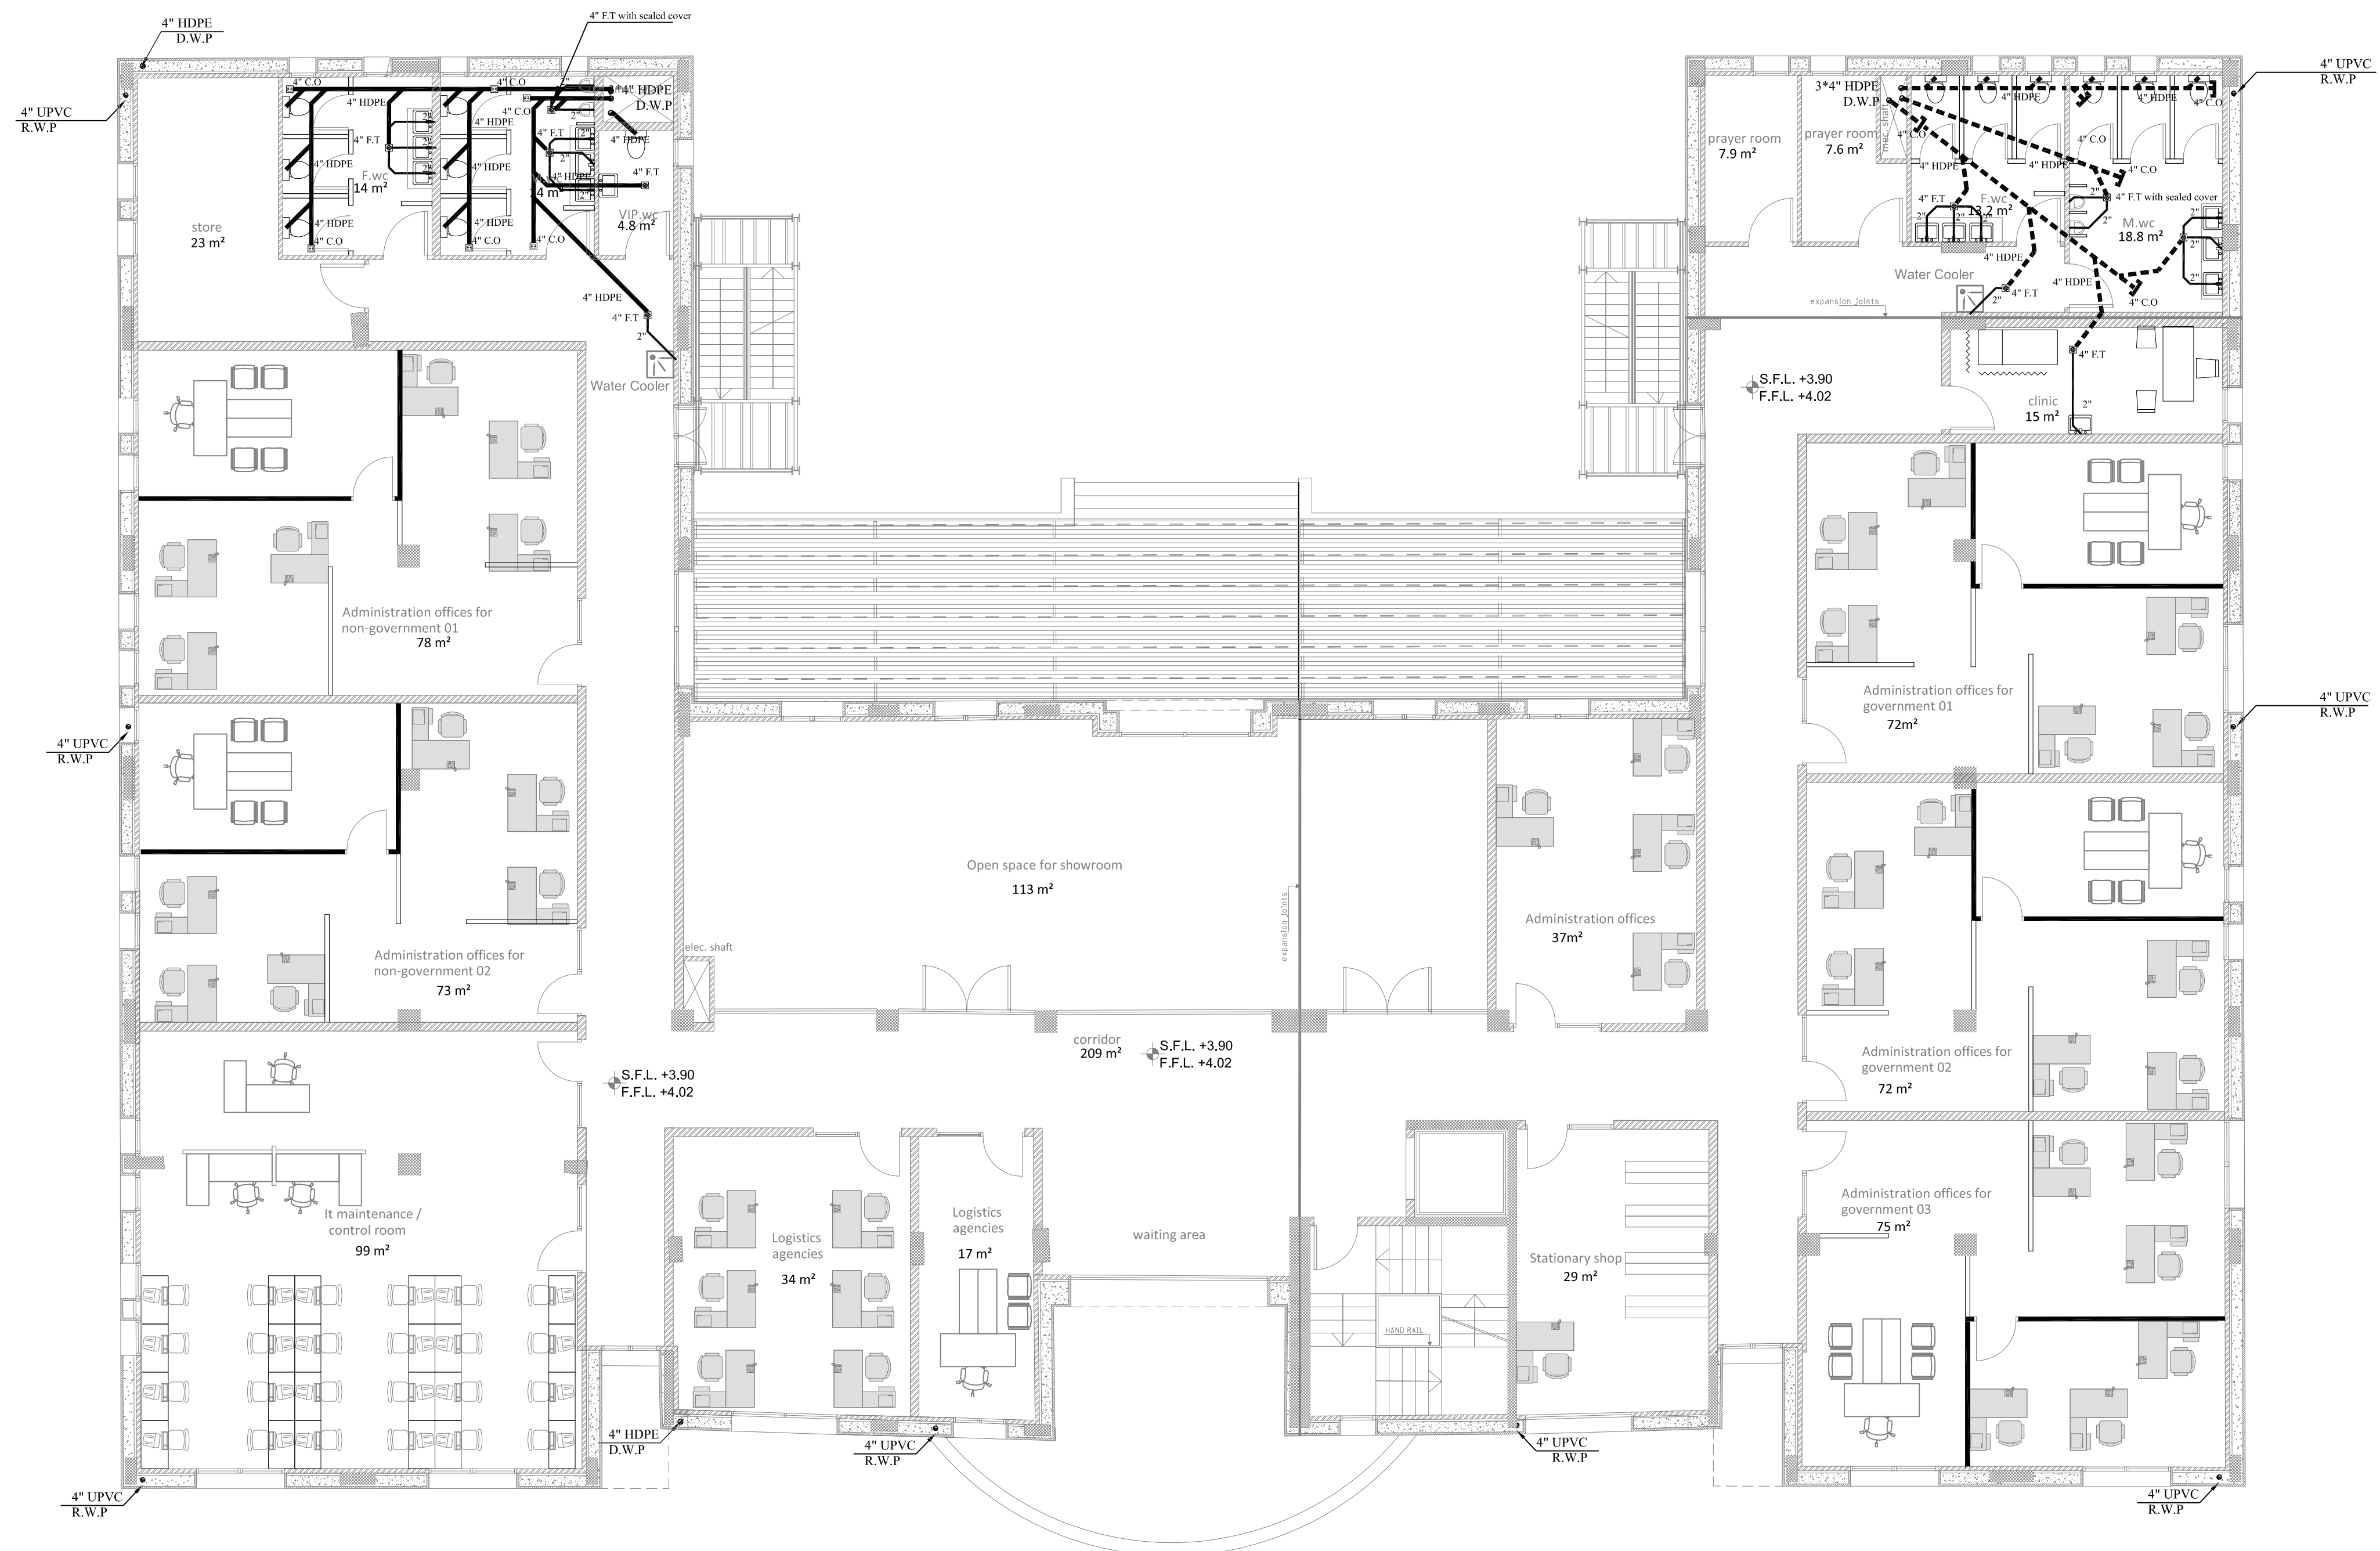

LEGEND:

 - **SEWAGE MANHOLE**
- **Ø6" U.P.V.C DRAIN PIPE**
- **Ø4" U.P.V.C DRAIN SUSPENDED PIPE**
- **Ø4" U.P.V.C DRAIN PIPE-U.T**
- **Ø2" U.P.V.C DRAIN PIPE-U.T**
- **4" FLOOR TRAP**
- **4" FLOOR CLEAN OUT**
- **ROOF DRAIN**
- **Ø4" UPVC DRAIN & VENT RISER**
- **SUSPENDE CLEAN OUT**
- T/A**
F/A
U.T

TO ABOVE
FROM ABOVE
UNDER TILES
- **SINK**
- **WESTERN W.C**
- **HANDICAPPED W.C**
- **LAVATORY**
- **WATER COOLER**
- **WATER GRILL**

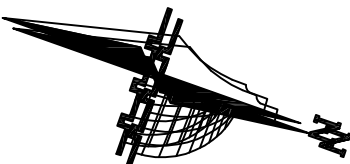


G.		
F.		
E.		
C.	THIRD REVISION	29/8/2018
B.	SECOND REVISION	7/8/2018
A.	FIRST REVISION	24/7/2018
Rev. No.	Rev. Description	Date




PIEFZA



UNDP

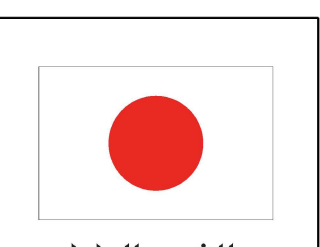

من الشعب الياباني
From the People of Japan

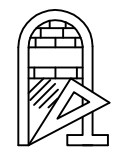


AL AMEED
Architects & Engineers
NABLUS Tel. 09-2340472 / 2340610 Fax:09-2341302 P.o.Box 1112




PROJECT TITLE
Construction of Two Additional Floors to the Administration Building at Jericho Agro-Industrial Park
JERICHO

DRAWING Title
**FIRST FLOOR PLAN
DRAINAGE SYSTEM**

ARCHITECTURAL : NAHEEL YOUNES		
DRAWN : RANA HINDIA		
CHECKED : RAMI MALHIS		
APPROVED : RAMI MALHIS		
SCALE 1:100	DATE 9/ 2018	DRAWING NO. M-101

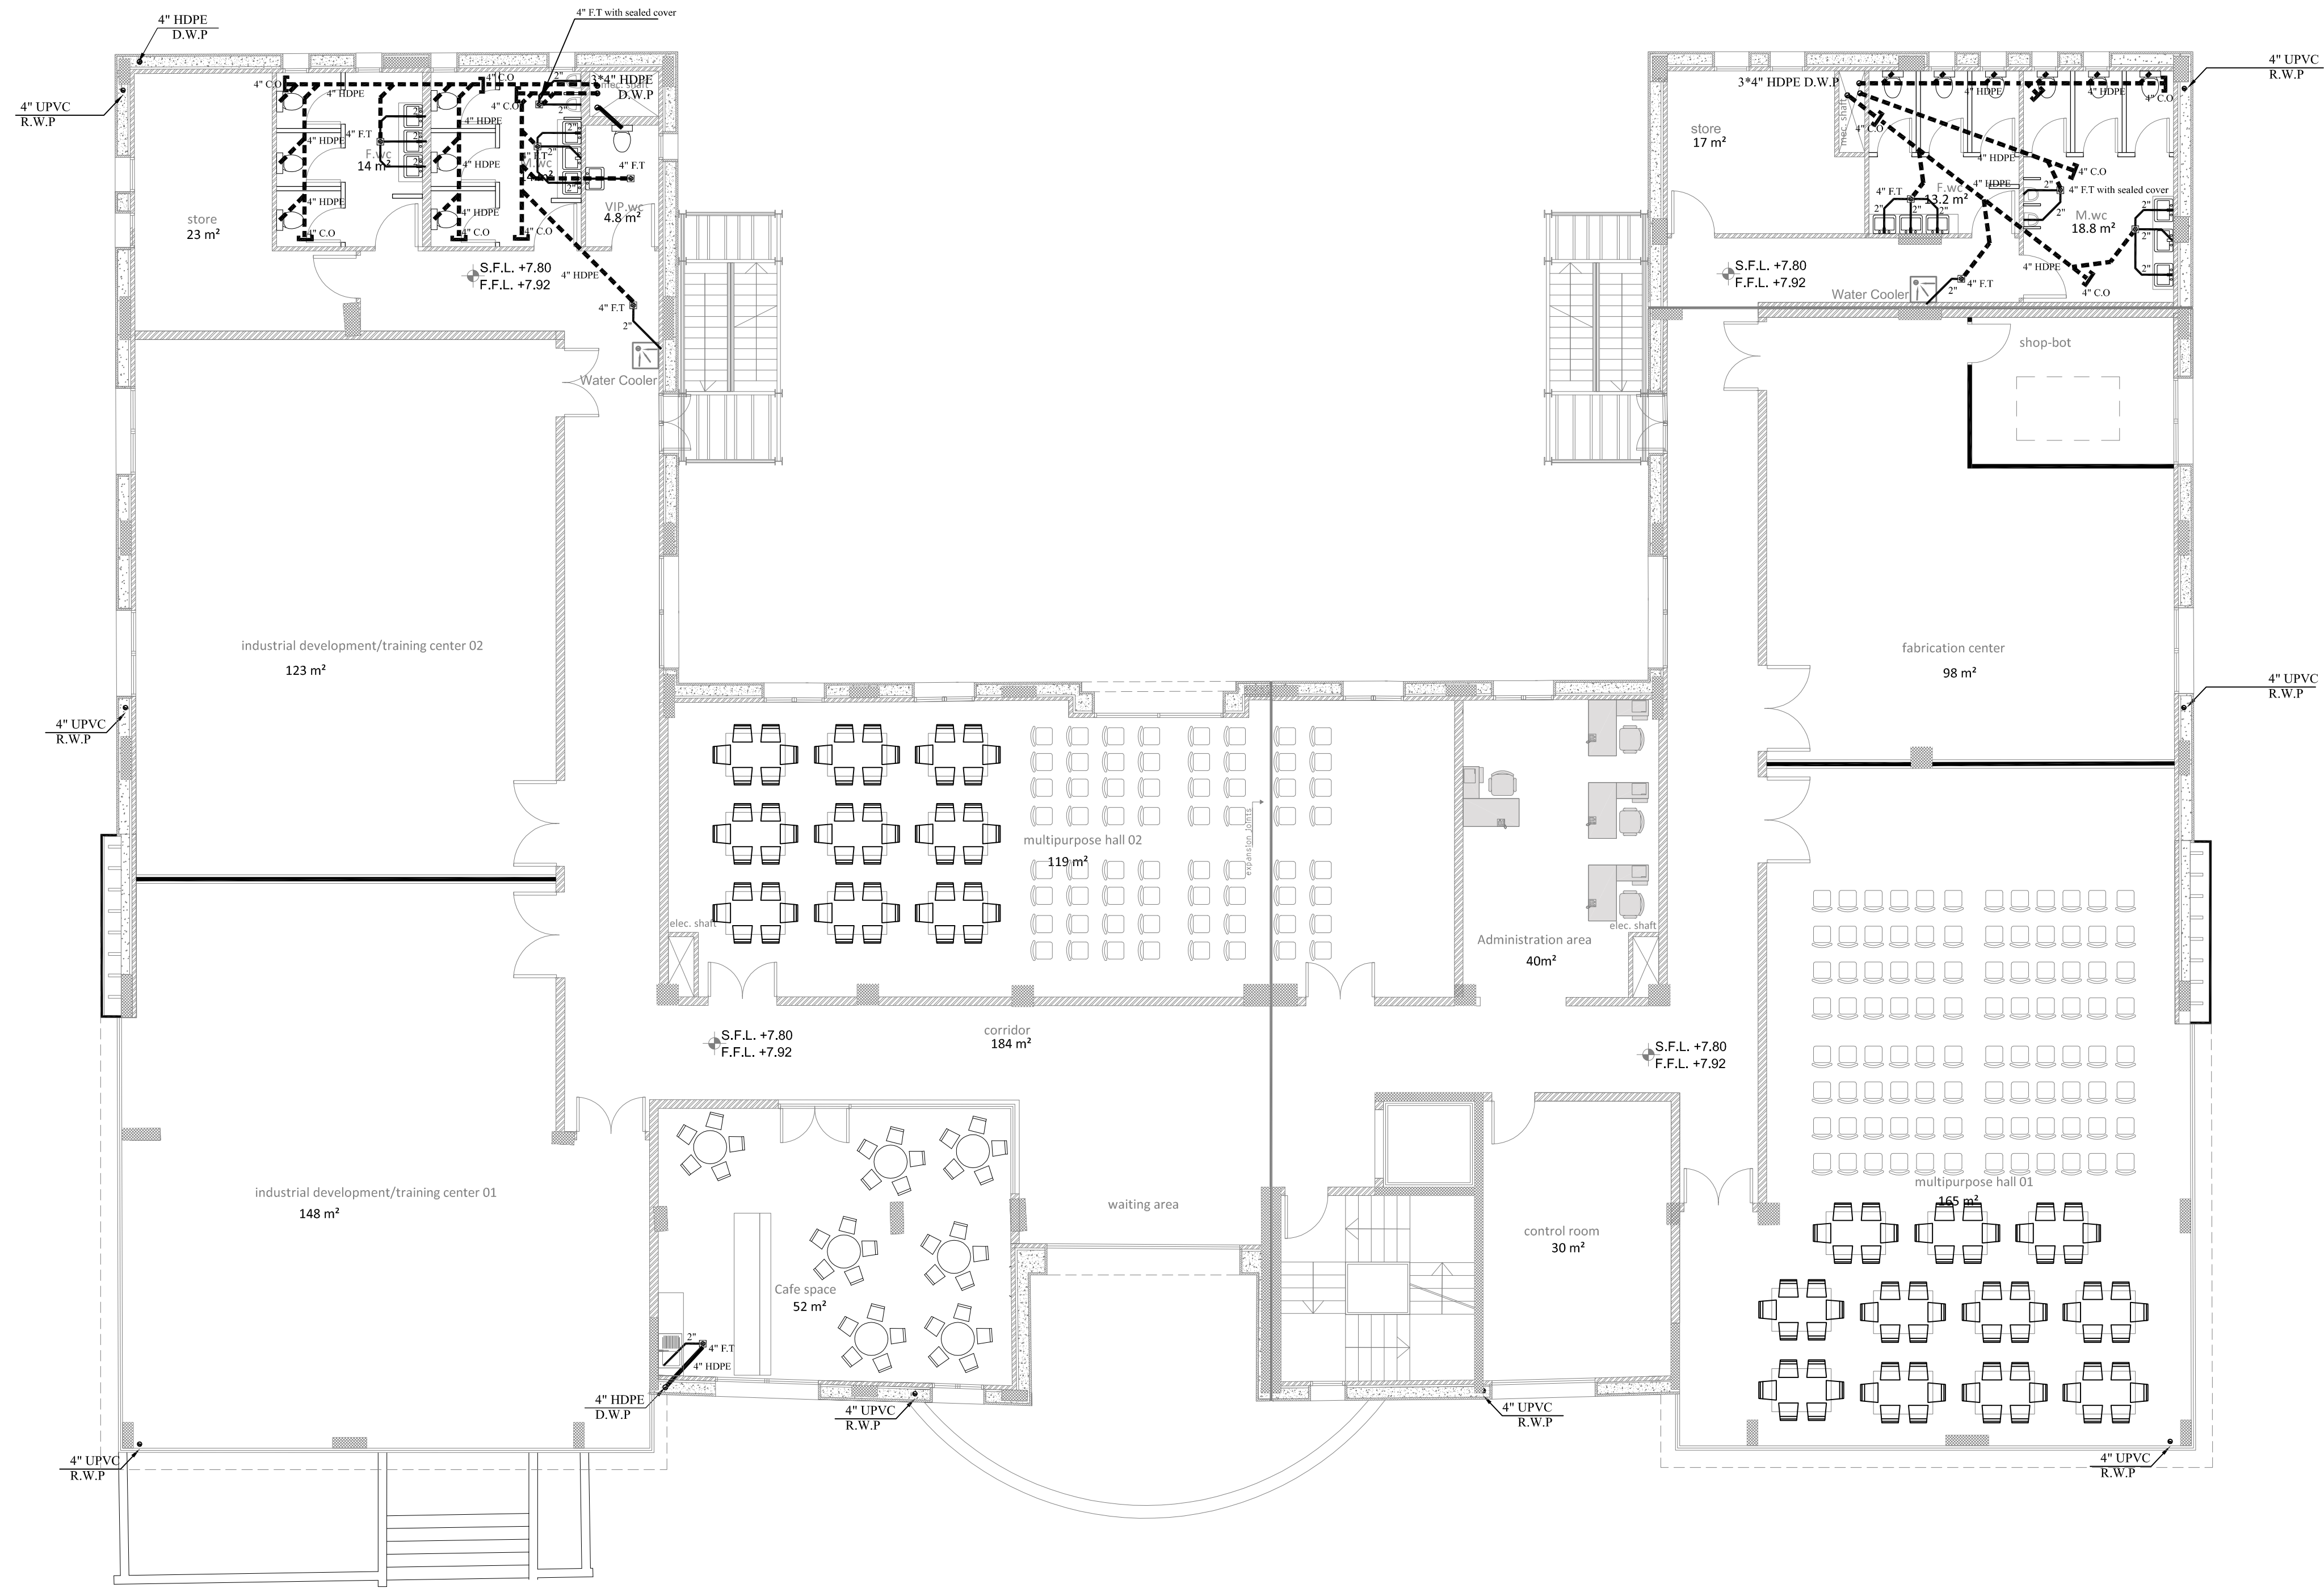

LEGEND:

   - **SEWAGE MANHOLE**
- **Ø6" U.P.V.C DRAIN PIPE**
- **Ø4" U.P.V.C DRAIN SUSPENDED PIPE**
- **Ø4" U.P.V.C DRAIN PIPE-U.T**
- **Ø2" U.P.V.C DRAIN PIPE-U.T**
- **4" FLOOR TRAP**
- **4" FLOOR CLEAN OUT**
- **ROOF DRAIN**
- **Ø4" UPVC DRAIN & VENT RISER**
- **SUSPENDE CLEAN OUT**
- T/A


F/A

U.T

TO ABOVE

FROM ABOVE

UNDER TILES
- **SINK**
- **WESTERN W.C**
- **HANDICAPPED W.C**
- **LAVATORY**
- **WATER COOLER**
- **WATER GRILL**

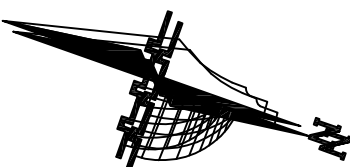


G.		
F.		
E.		
C.	THIRD REVISION	29/8/2018
B.	SECOND REVISION	7/8/2018
A.	FIRST REVISION	24/7/2018
Rev. No.	Rev. Description	Date




PIEFZA



UNDP

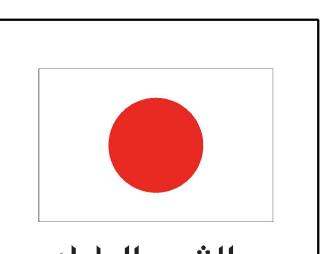

من الشعب الياباني
From the People of Japan

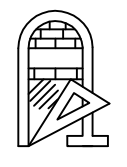


AL AMEED
Architects & Engineers
NABLUS Tel. 09-2340472 / 2340610 Fax:09-2341302 P.o.Box 1112

PROJECT TITLE
Construction of Two Additional Floors to the Administration Building at Jericho Agro-Industrial Park
JERICHO


DRAWING Title
**SECOND FLOOR PLAN
DRAINAGE SYSTEM**

ARCHITECTURAL : NAHEEL YOUNES		
DRAWN : RANA HINDIA		
CHECKED : RAMI MALHIS		
APPROVED : RAMI MALHIS		
SCALE	DATE	DRAWING NO.
1:100	9/ 2018	M-102

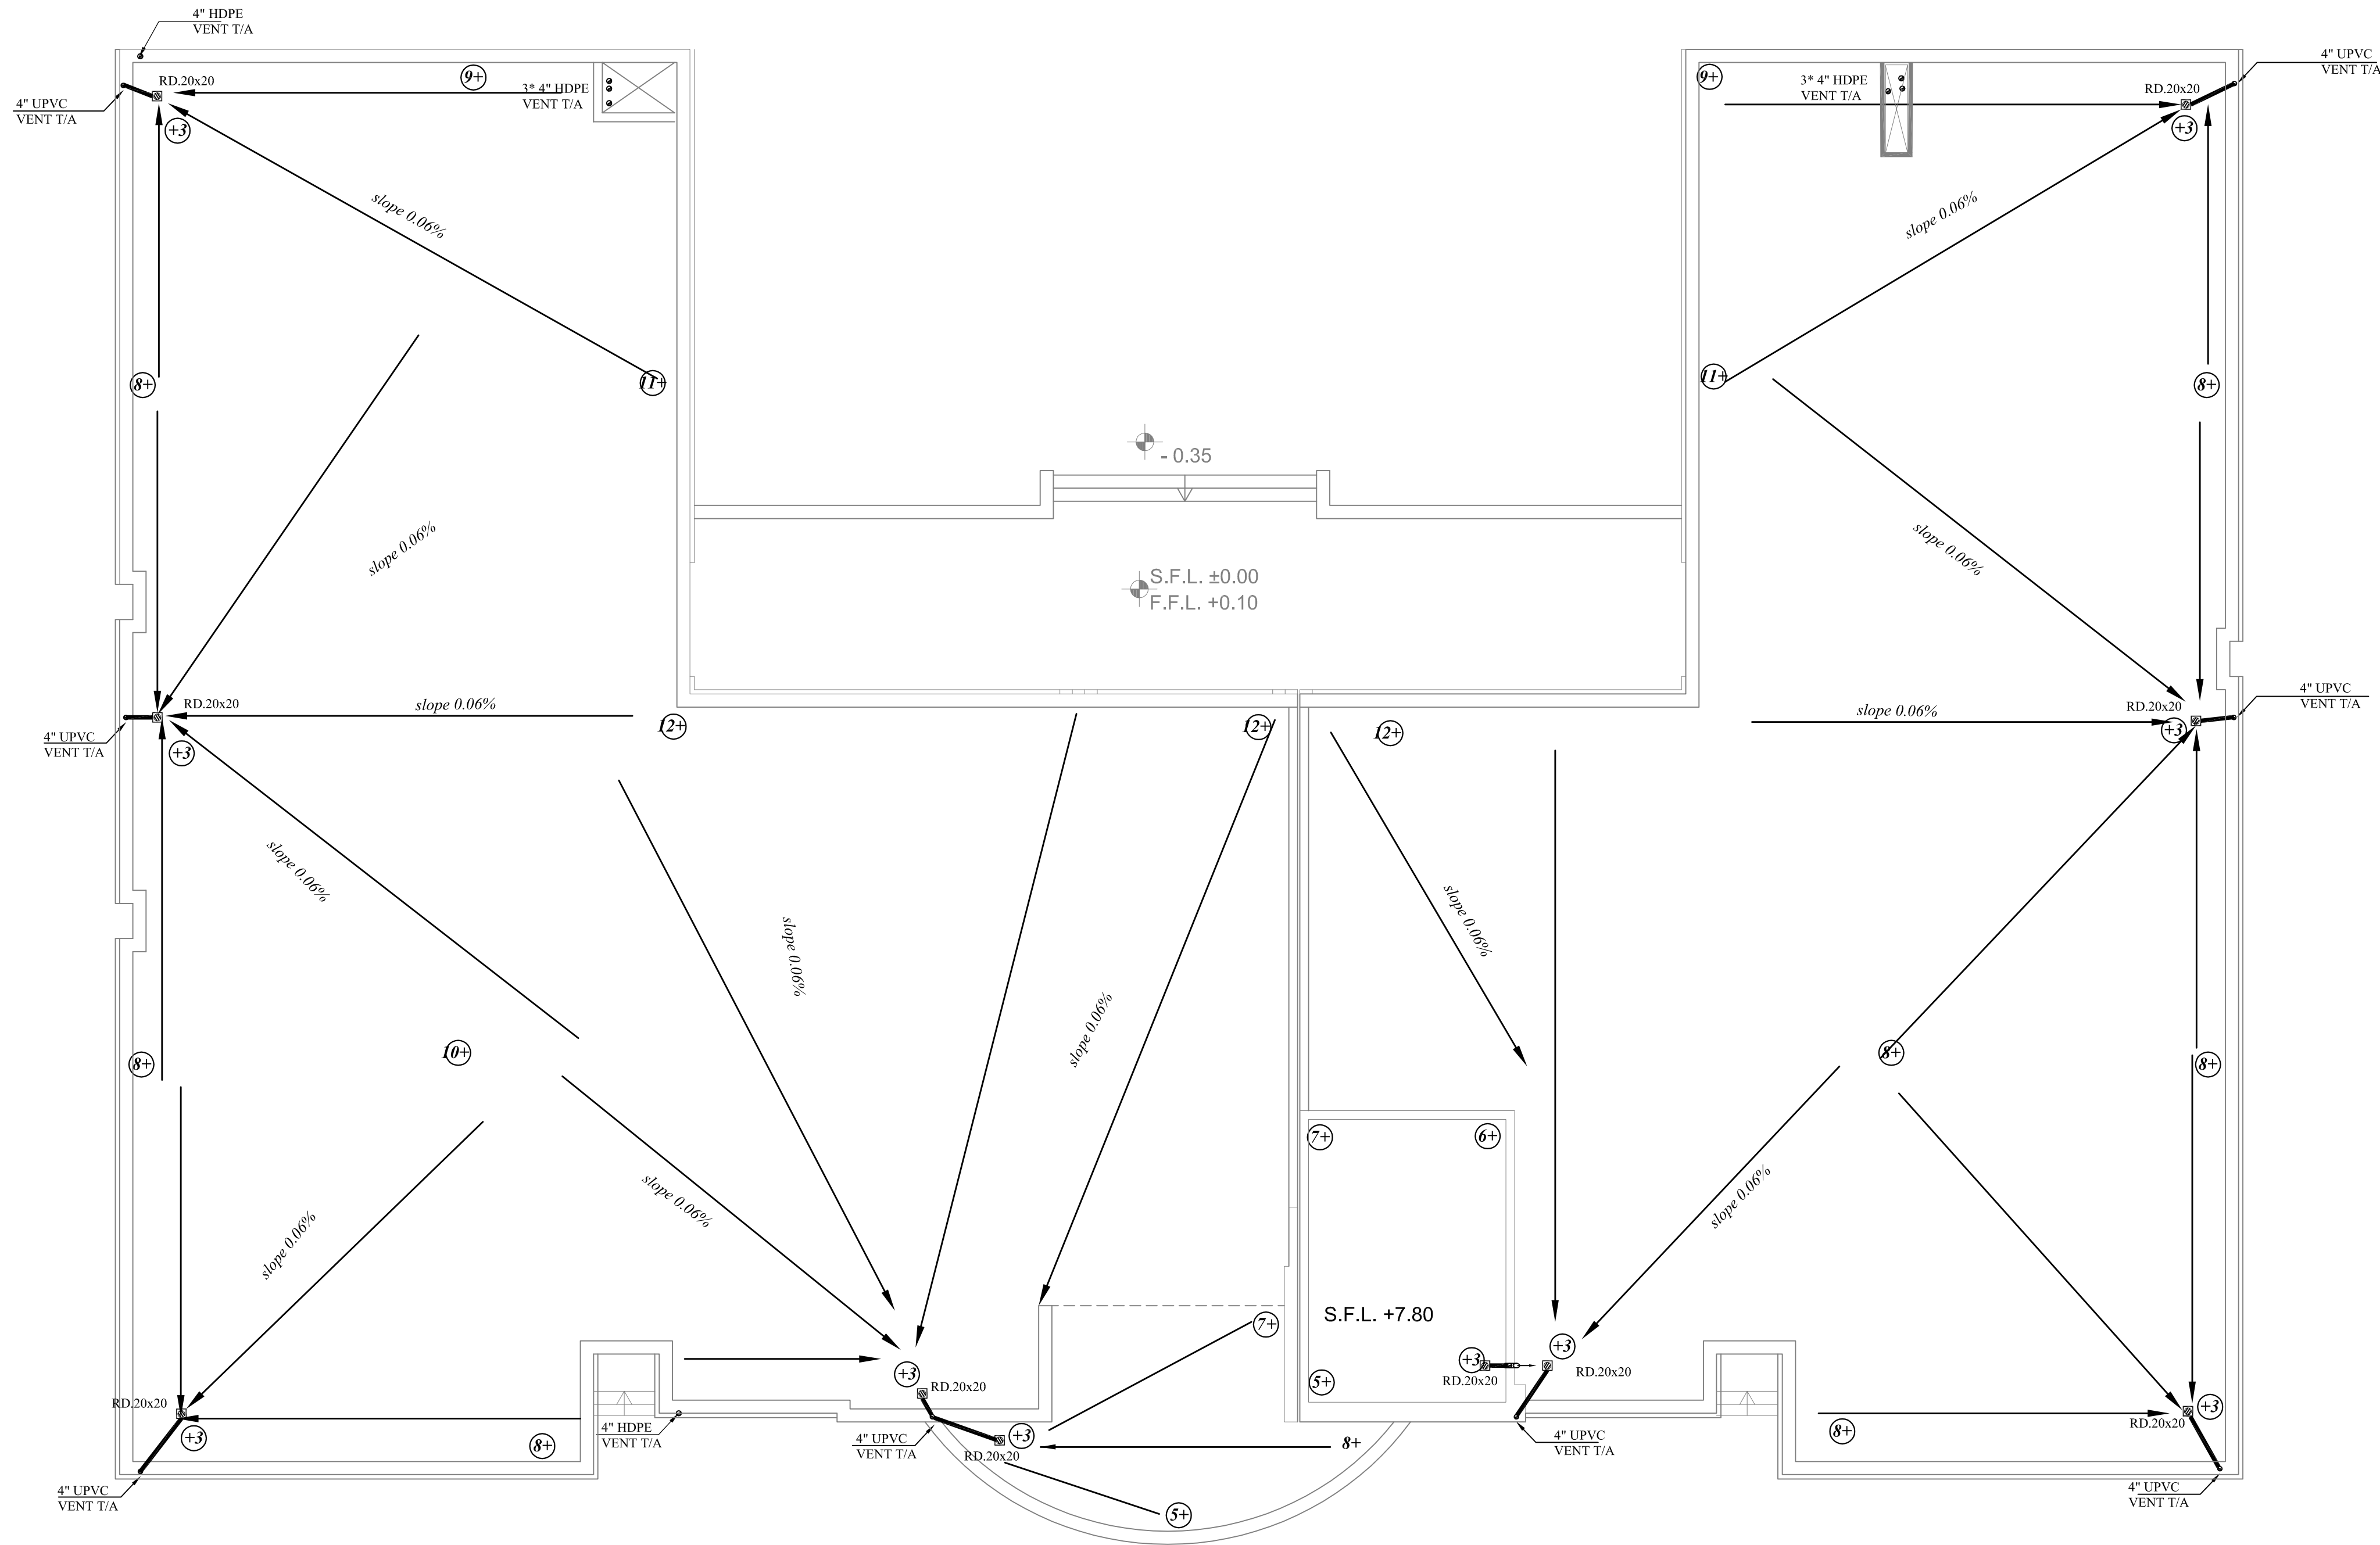

LEGEND:

- SEWAGE MANHOLE**
- Ø6" U.P.V.C DRAIN PIPE**
- Ø4" U.P.V.C DRAIN SUSPENDED PIPE**
- Ø4" U.P.V.C DRAIN PIPE-U.T**
- Ø2" U.P.V.C DRAIN PIPE-U.T**
- 4" FLOOR TRAP**
- 4" FLOOR CLEAN OUT**
- ROOF DRAIN**
- Ø4" UPVC DRAIN & VENT RISER**
- SUSPENDE CLEAN OUT**
- T/A**
- F/A**
- U.T**
- TO ABOVE**
- FROM ABOVE**
- UNDER TILES**
- SINK**
- WESTERN W.C**
- HANDICAPPED W.C**
- LAVATORY**
- WATER COOLER**
- WATER GRILL**

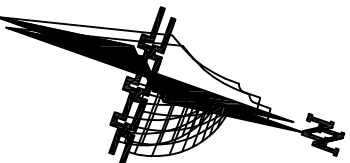


G.		
F.		
E.		
C.	THIRD REVISION	29/8/2018
B.	SECOND REVISION	7/8/2018
A.	FIRST REVISION	24/7/2018
Rev. No.	Rev. Description	Date



PIEFZA



UNDP

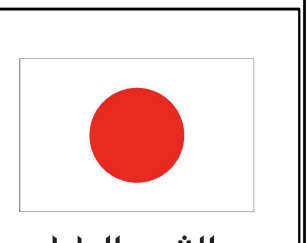

من الشعب الياباني
From the People of Japan




AL AMEED
Architects & Engineers
NABLUS Tel. 09-2340472 / 2340610 Fax:09-2341302 P.o.Box 1112

PROJECT TITLE
Construction of Two Additional Floors to the Administration
Building at Jericho Agro-Industrial Park
JERICHO


DRAWING Title
**TOP ROOF FLOOR PLAN
DRAINAGE SYSTEM**

ARCHITECTURAL : NAHEEL YOUNES	
DRAWN : RANA HINDIA	
CHECKED : RAMI MALHIS	
APPROVED : RAMI MALHIS	
SCALE 1:100	DATE 9/ 2018
DRAWING NO. M-103	

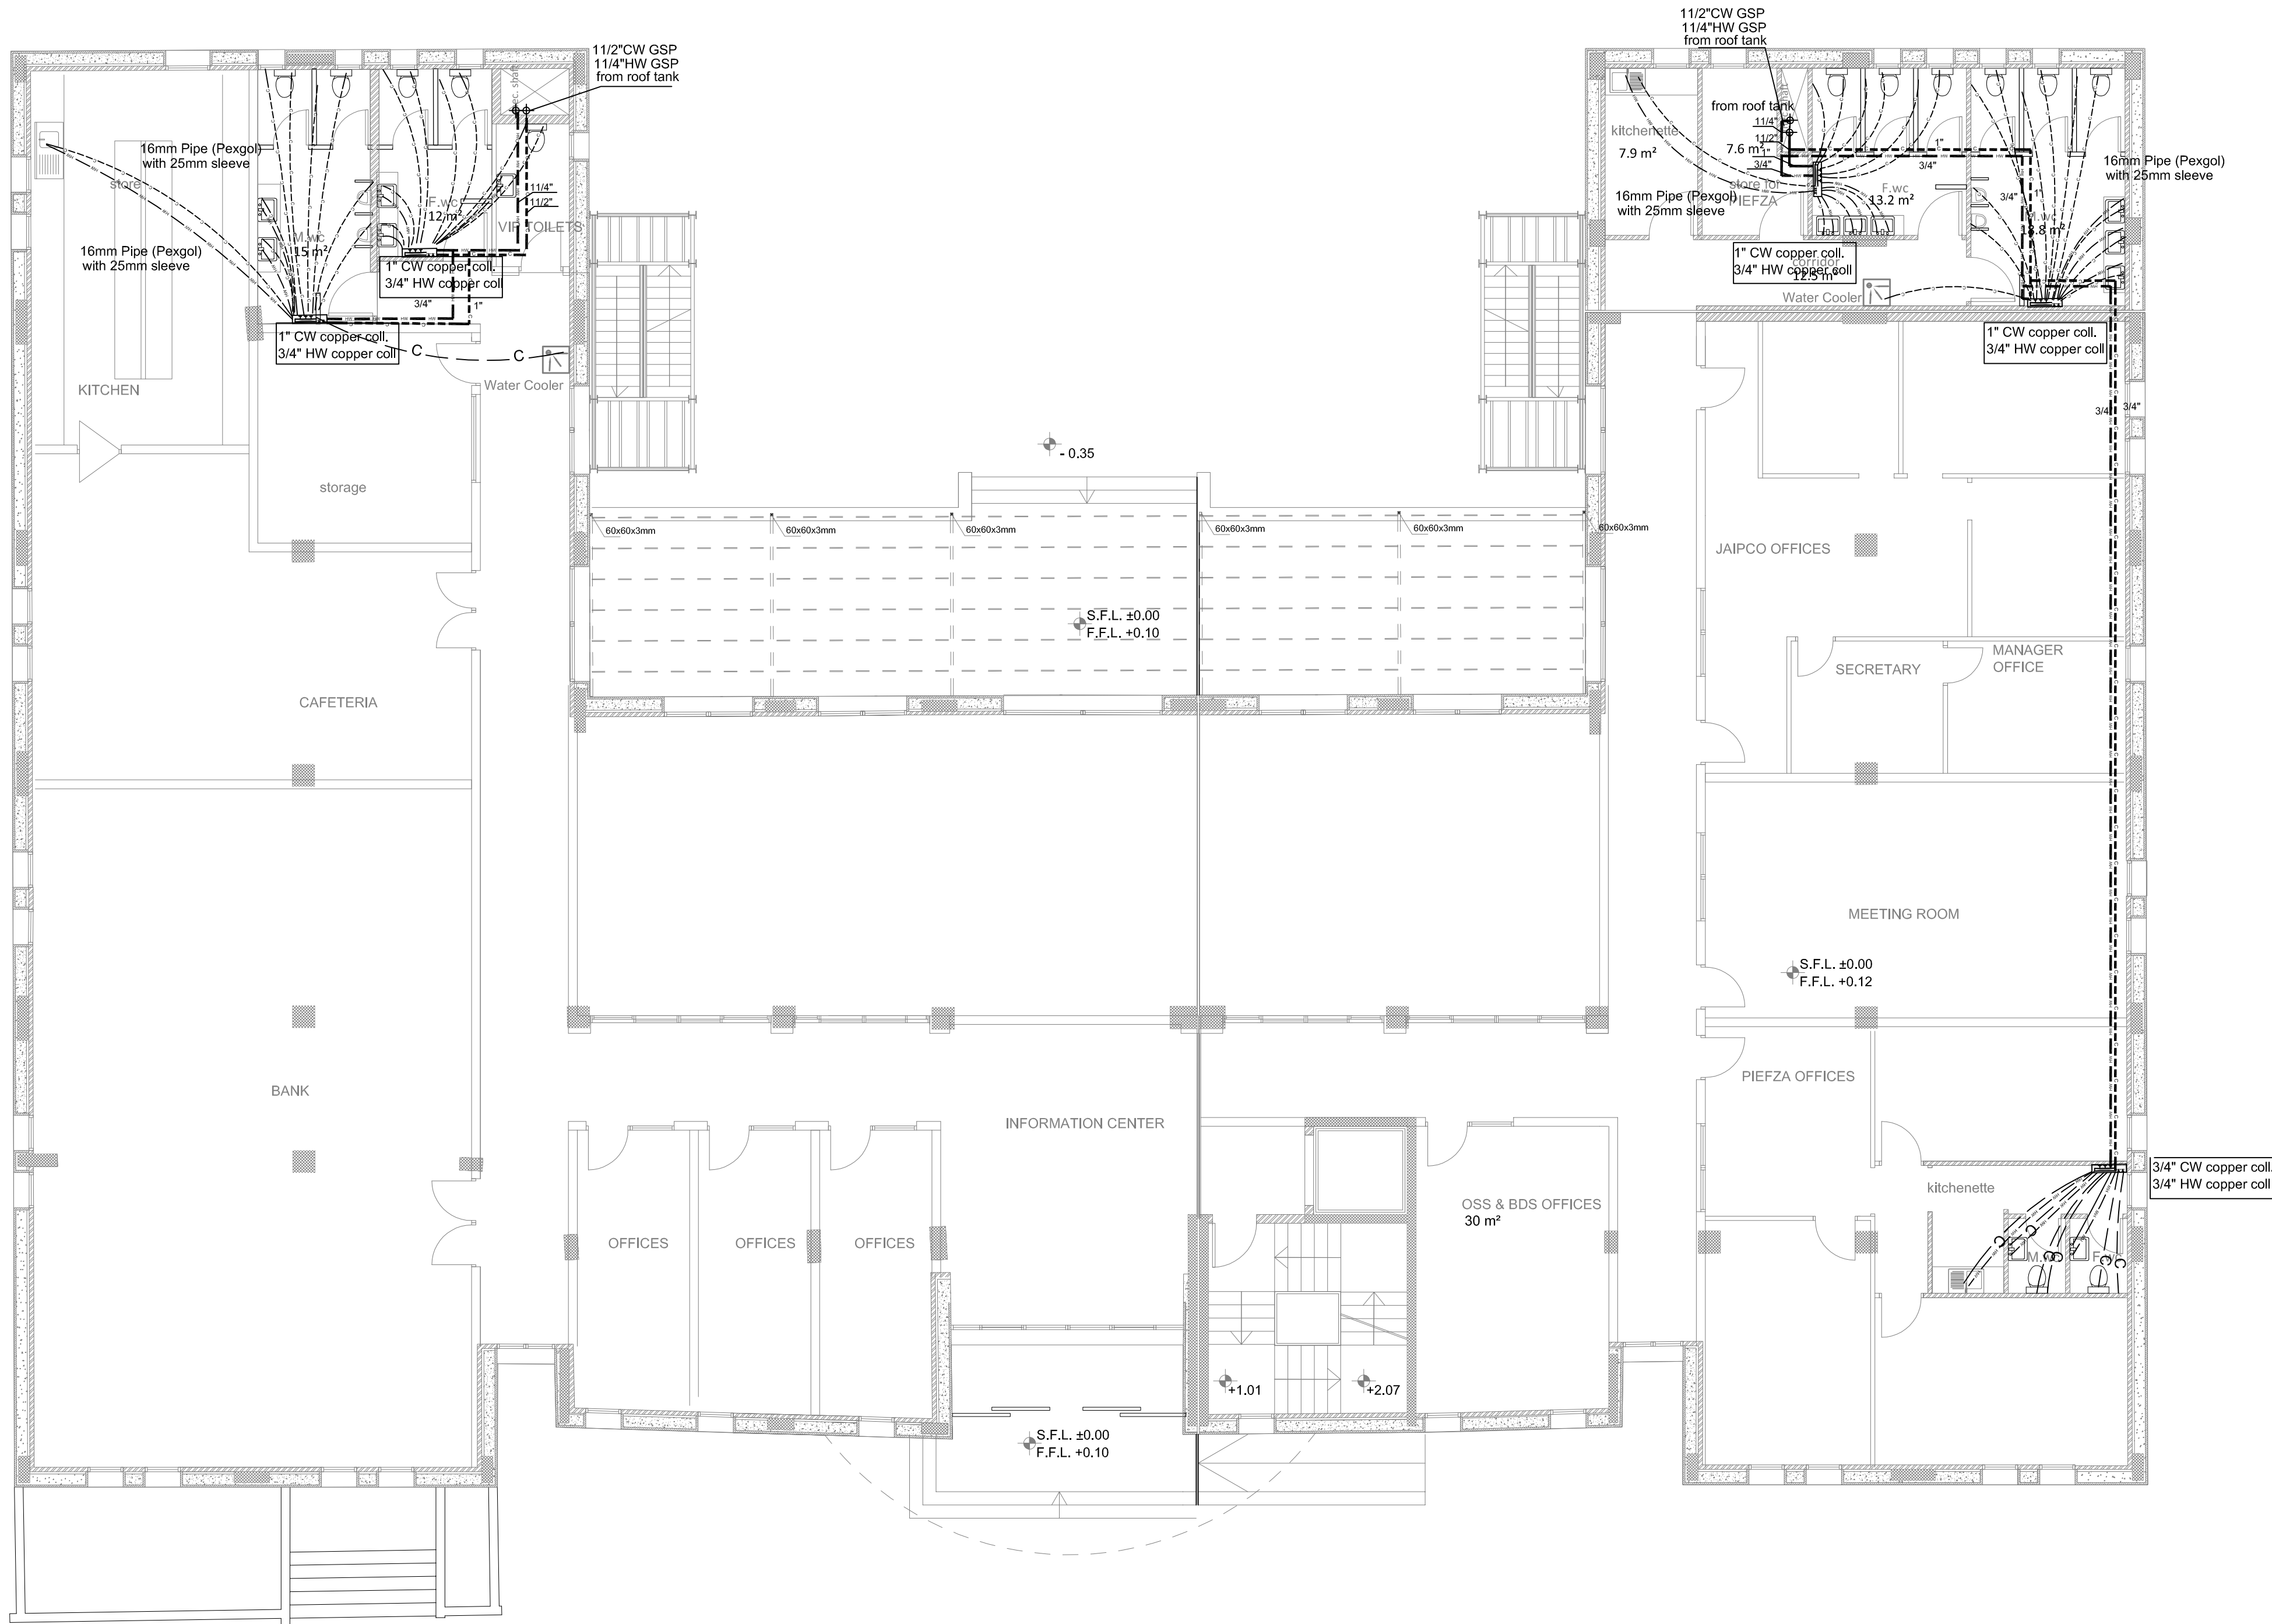

LEGEND

- COLD WATER PIPE
CITY WATER PIPE
HOT WATER PIPE
16MM PIPE (PEX)
H&C WATER COLLECTOR
WATER METER
PUMP
ELEC. BOILER 80L
ELEC. BOILER 60L
NON RETERN VALVE
GALVANIZE STEEL PIPE
WATER TANK 1500L
VALVE
WATER COOLER

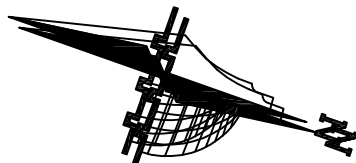

G.		
F.		
E.		
C.	THIRD REVISION	29/8/2018
B.	SECOND REVISION	7/8/2018
A.	FIRST REVISION	24/7/2018
Rev. No.	Rev. Description	Date




AL AMEED
Architects & Engineers
NABLUS Tel. 09-2340472 / 2340610 Fax:09-2341302 P.o.Box 1112

PROJECT TITLE
Construction of Two Additional Floors to the Administration
Building at Jericho Agro-Industrial Park
JERICHO


DRAWING Title
**GROUND FLOOR PLAN
WATER SUPPLY SYSTEM**

ARCHITECTURAL : NAHEEL YOUNES	
DRAWN : RANA HINDIA	
CHECKED : RAMI MALHIS	
APPROVED : RAMI MALHIS	
SCALE 1:100	DATE 9/ 2018
DRAWING NO. M-200	

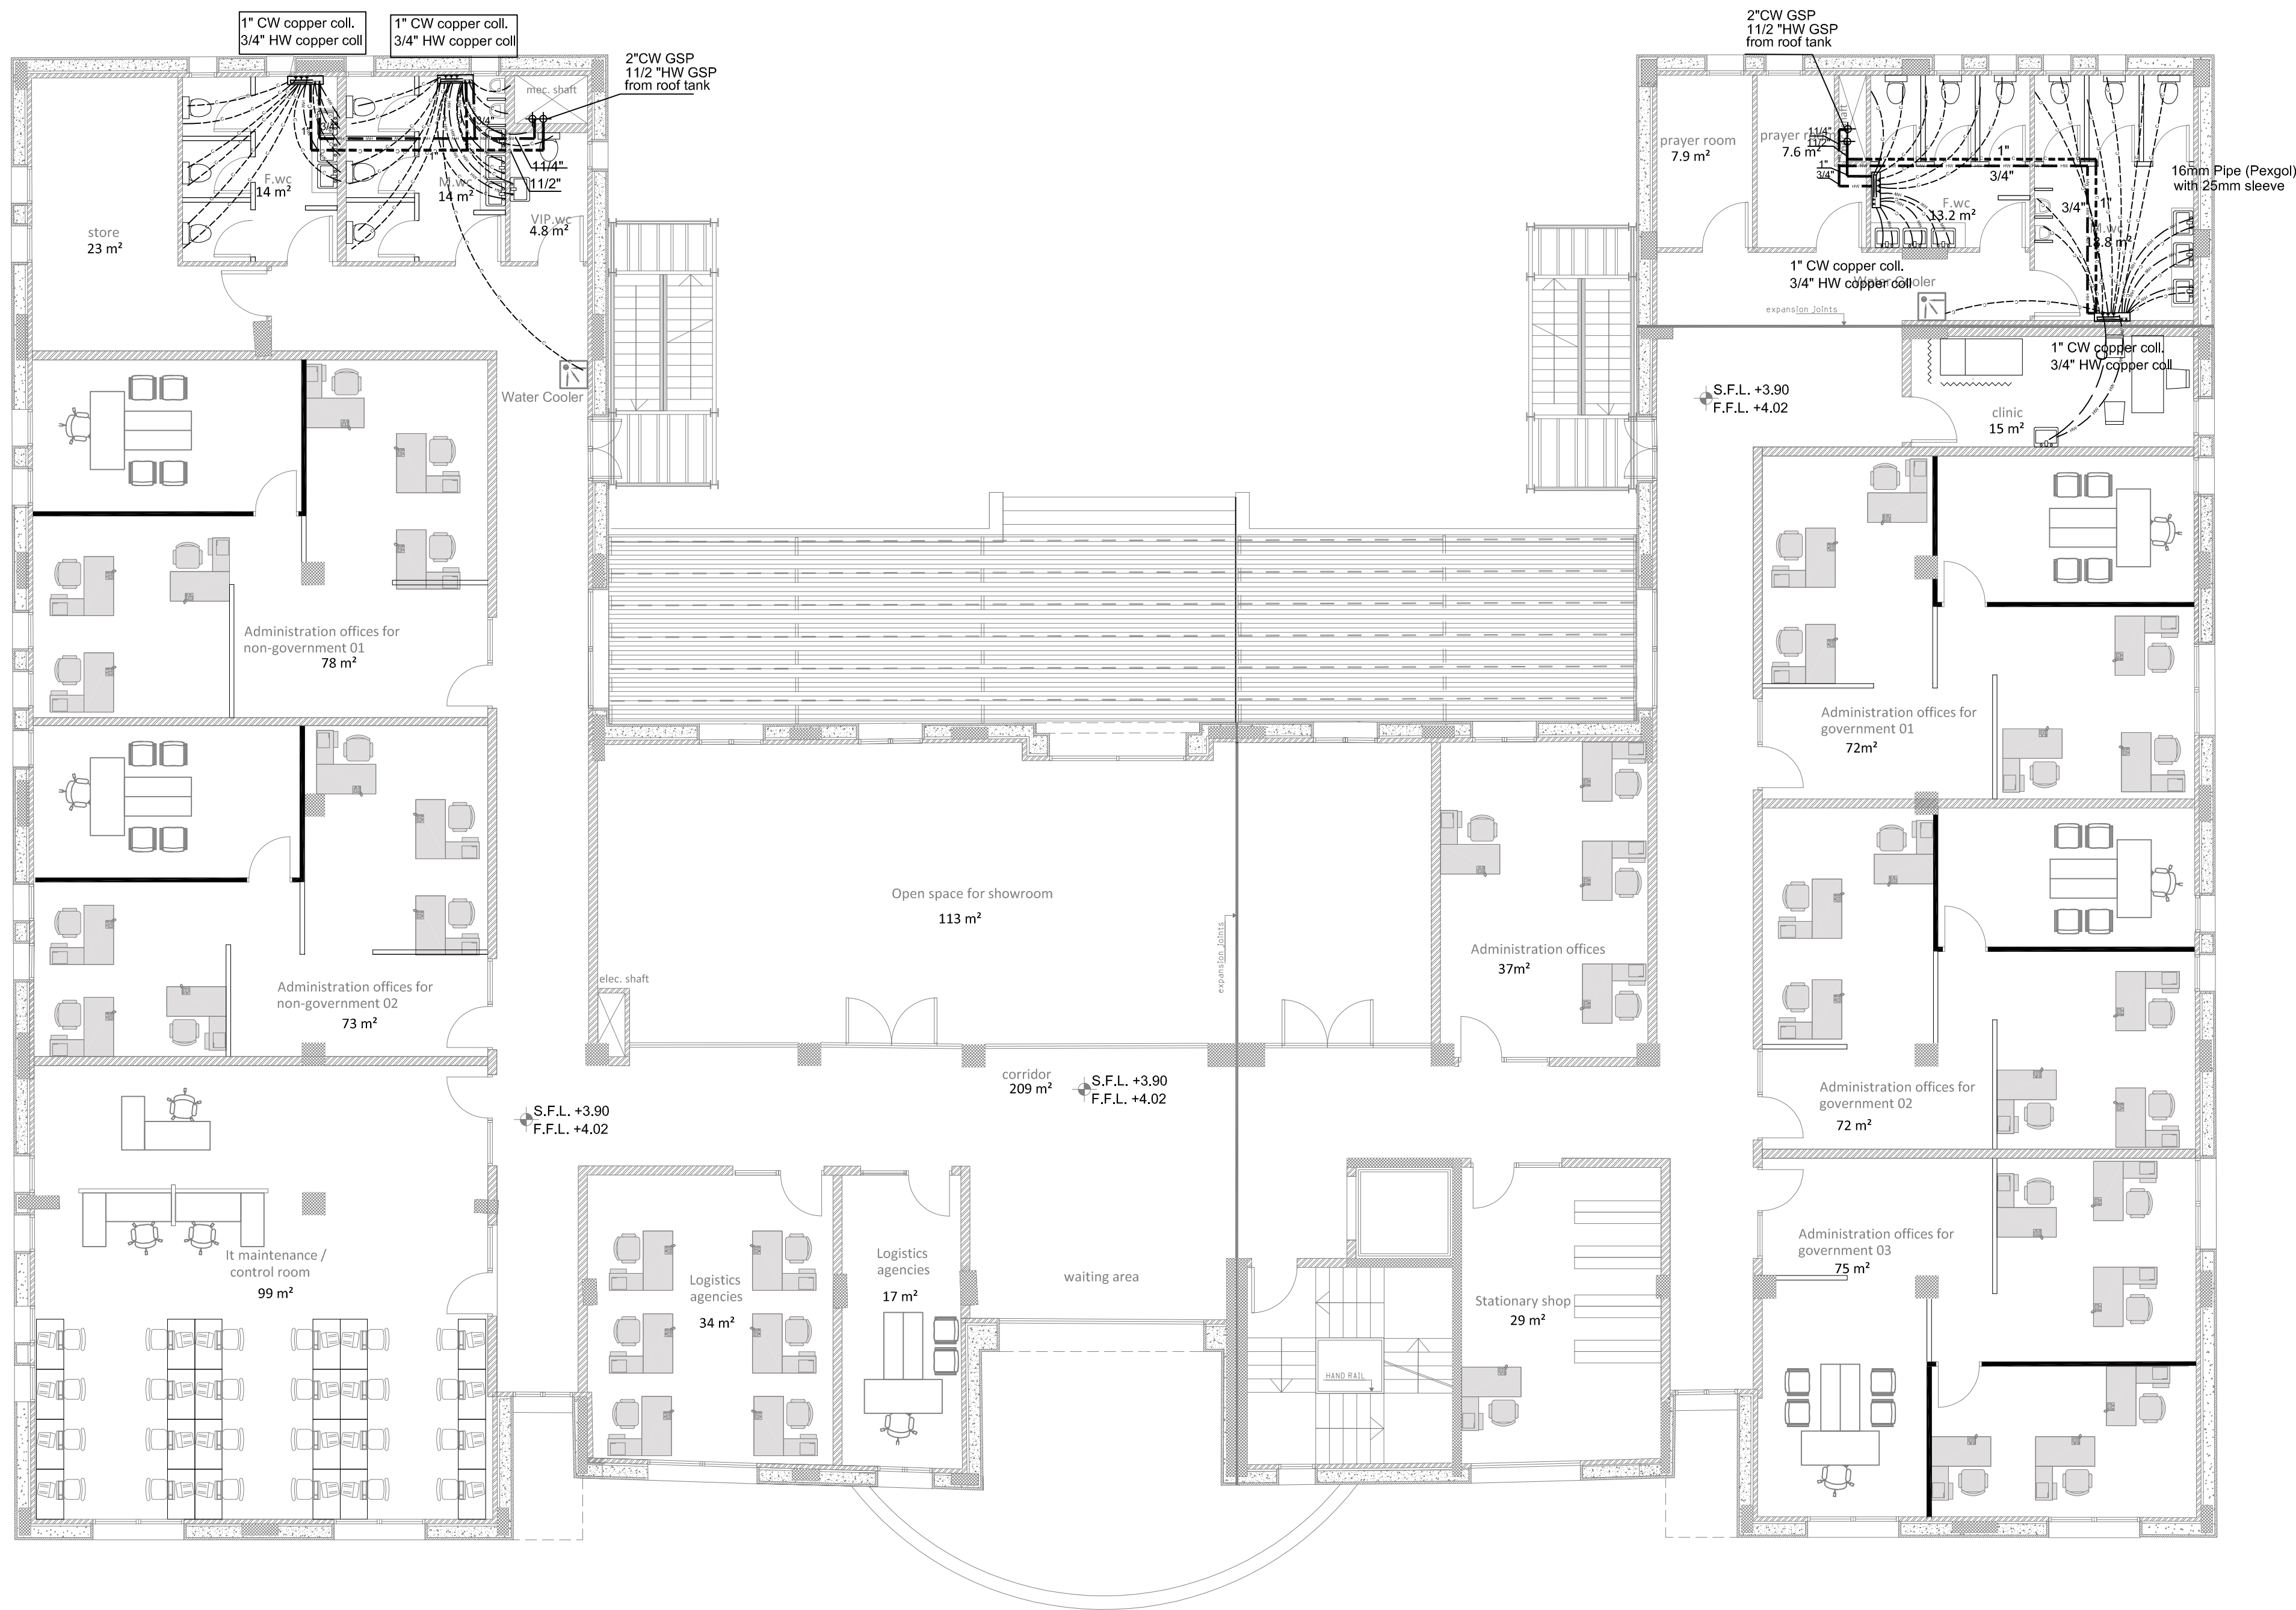

LEGEND

- COLD WATER PIPE
CITY WATER PIPE
HOT WATER PIPE
16MM PIPE (PEX)
H&C WATER COLLECTOR
WATER METER
PUMP
ELEC. BOILER 80L
ELEC. BOILER 60L
NON RETERN VALVE
GALVANIZE STEEL PIPE
WATER TANK 1500L
VALVE
WATER COOLER

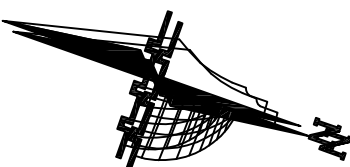


G.		
F.		
E.		
C.	THIRD REVISION	29/8/2018
B.	SECOND REVISION	7/8/2018
A.	FIRST REVISION	24/7/2018
Rev. No.	Rev. Description	Date




PIEFZA



UNDP

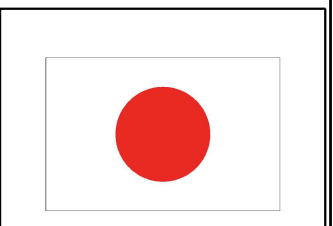

 من الشعب الياباني
From the People of Japan




AL AMEED
Architects & Engineers
NABLUS Tel. 09-2340472 / 2340610 Fax:09-2341302 P.o.Box 1112

PROJECT TITLE
Construction of Two Additional Floors to the Administration Building at Jericho Agro-Industrial Park
JERICHO


DRAWING Title
FIRST FLOOR PLAN
WATER SUPPLY SYSTEM

ARCHITECTURAL : NAHEEL YOUNES	
DRAWN : RANA HINDIA	
CHECKED : RAMI MALHIS	
APPROVED : RAMI MALHIS	
SCALE 1:100	DATE 9/ 2018
DRAWING NO. M-201	

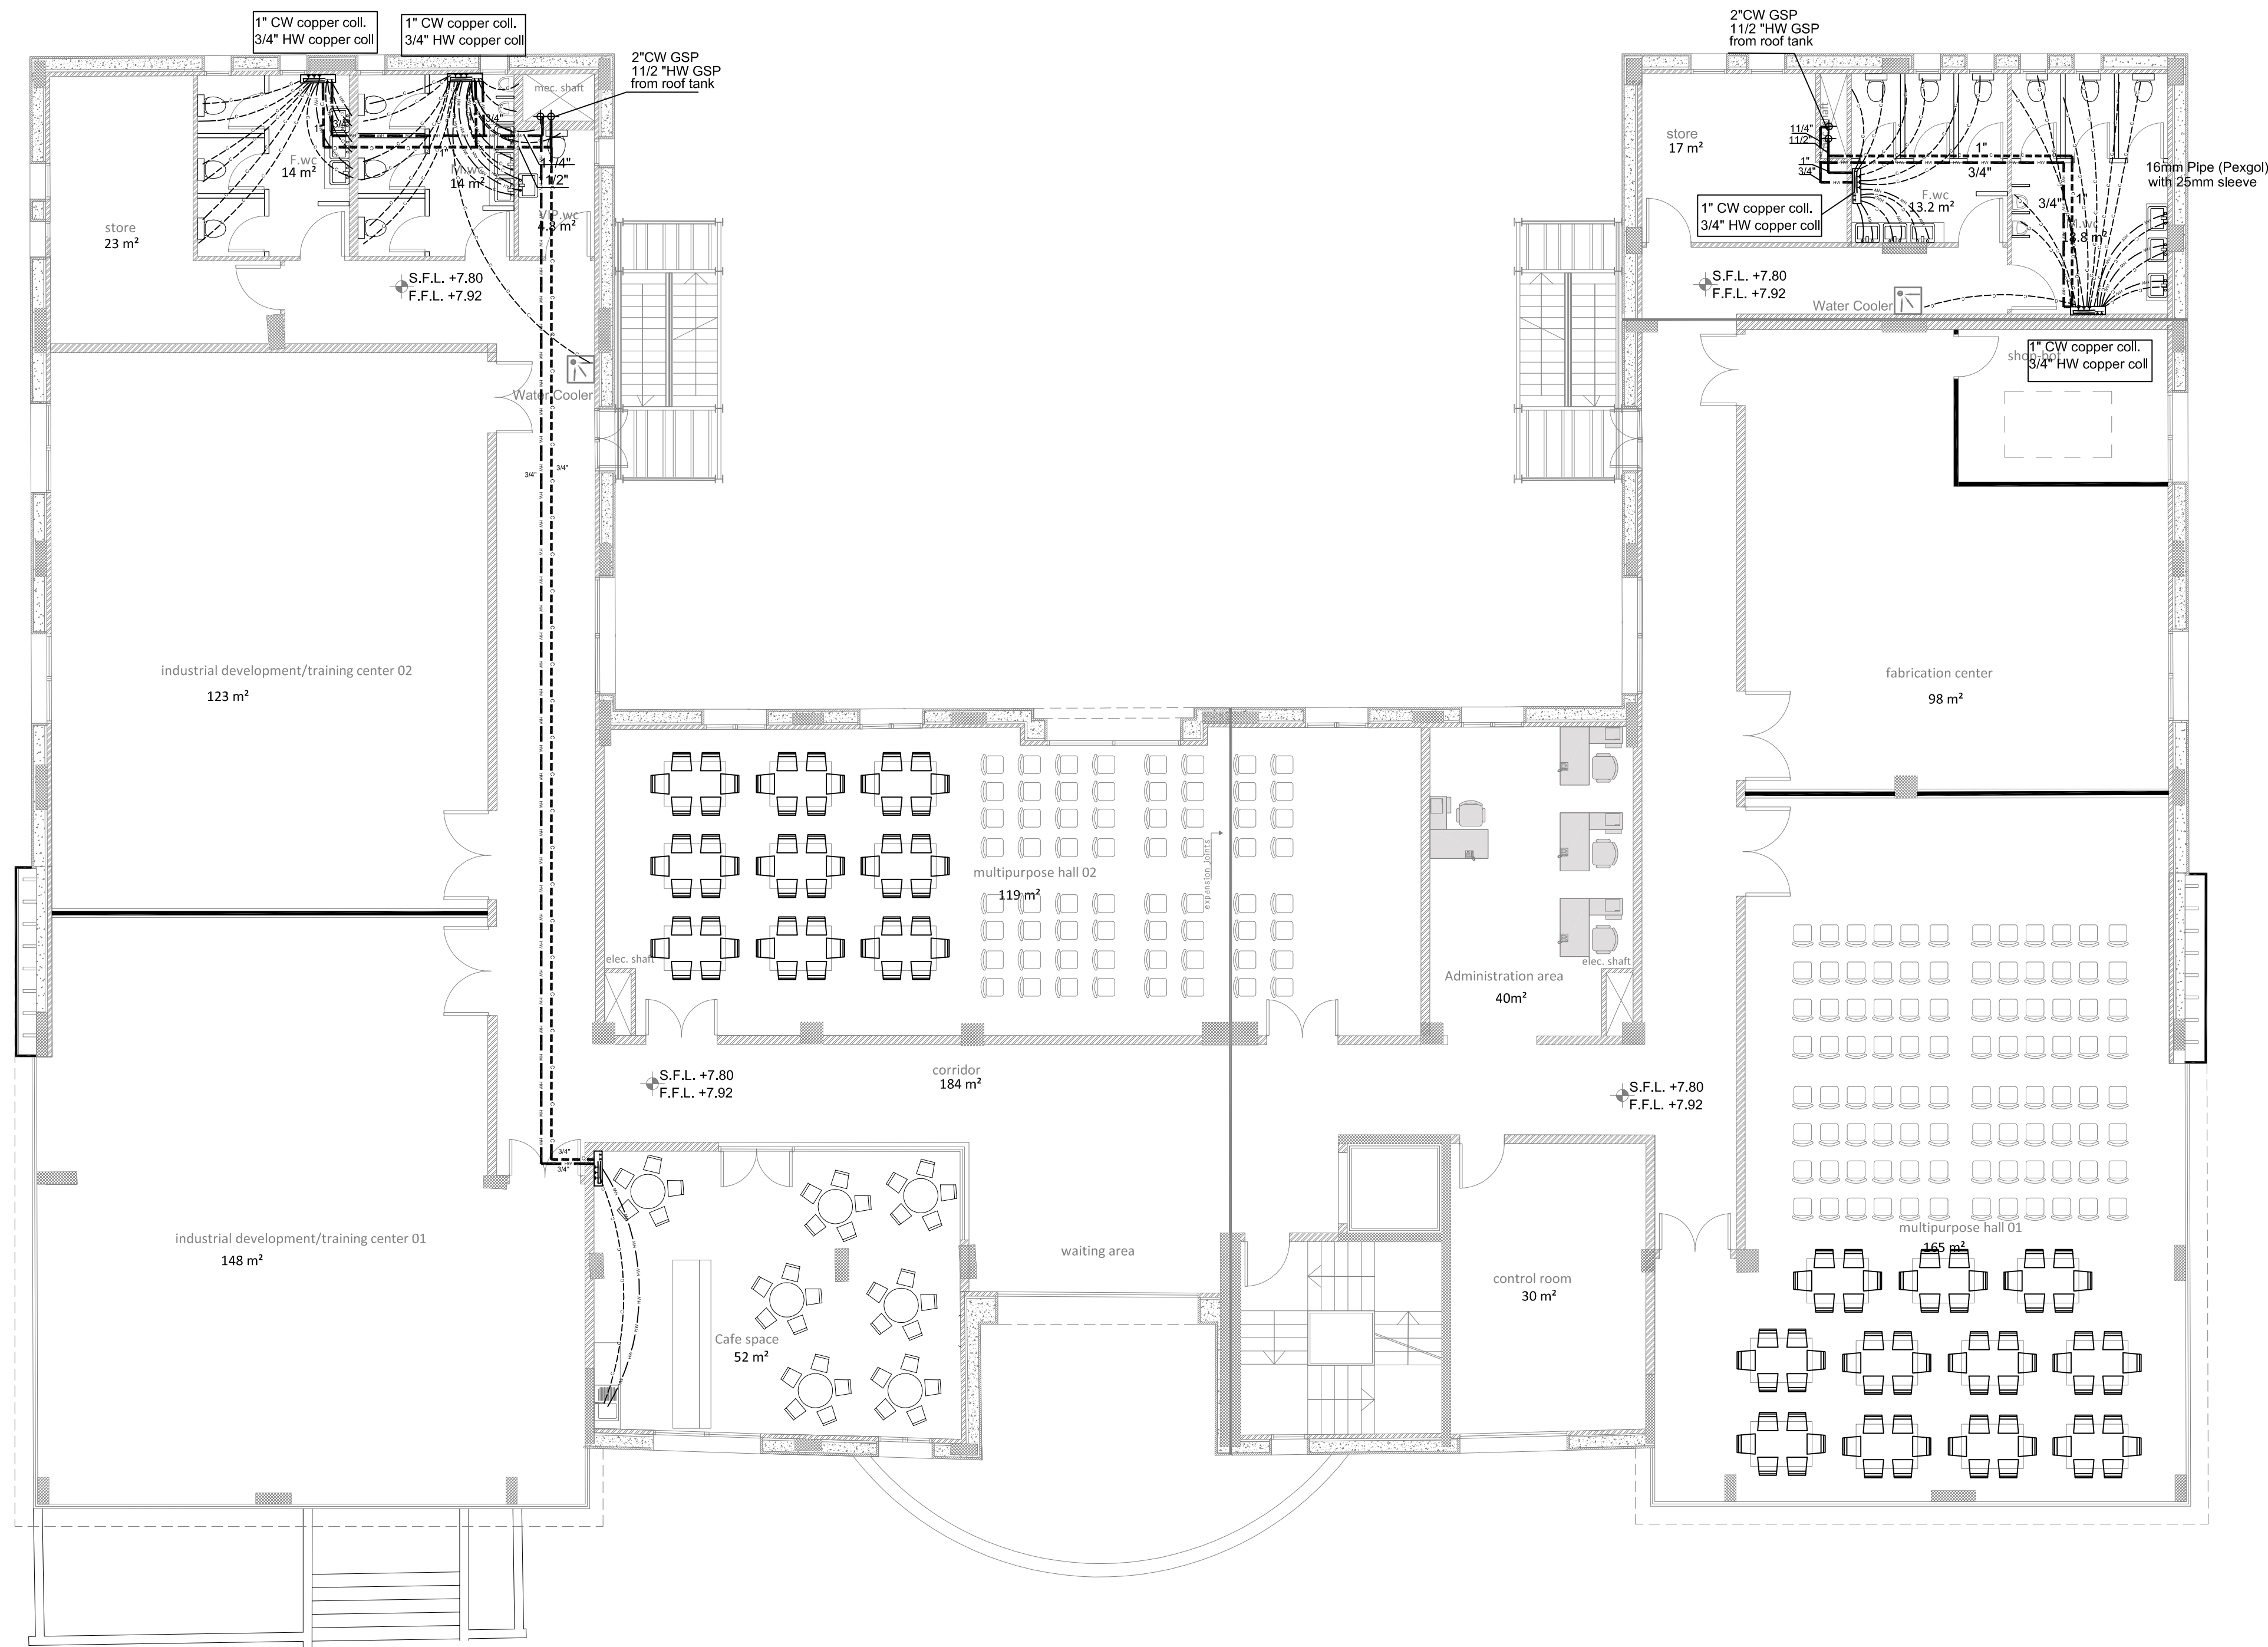

LEGEND

COLD WATER PIPE	----
CITY WATER PIPE	=====
HOT WATER PIPE	-----
16MM PIPE (PEX)	-----
H&C WATER COLLECTOR	▬
WATER METER	⊙
PUMP	⊙
ELEC. BOILER 80L	EB
ELEC. BOILER 60L	EB
NON RETERN VALVE	⊙
GALVANIZE STEEL PIPE	• G.S.P
WATER TANK 1500L	⊙
VALVE	⊙
WATER COOLER	⊙

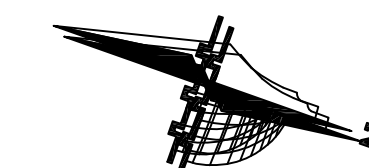


G.		
F.		
E.		
C.	THIRD REVISION	29/8/2018
B.	SECOND REVISION	7/8/2018
A.	FIRST REVISION	24/7/2018
Rev. No.	Rev. Description	Date



PIEZA



UNDP

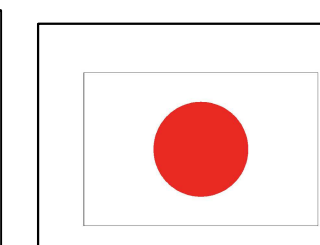

من الشعب الياباني
From the People of Japan




AL AMEED
Architects & Engineers

NABLUS Tel. 09-2340472 / 2340610 Fax 09-2341302 P.o.Box 1112



PROJECT TITLE
Construction of Two Additional Floors to the Administration
Building at Jericho Agro-Industrial Park
JERICHO


DRAWING Title
SECOND FLOOR PLAN
WATER SUPPLY SYSTEM

ARCHITECTURAL : NAHEEL YOUNES	
DRAWN : RANA HINDIA	
CHECKED : RAMI MALHIS	
APPROVED : RAMI MALHIS	
SCALE 1:100	DATE 9/ 2018
DRAWING NO. M-202	

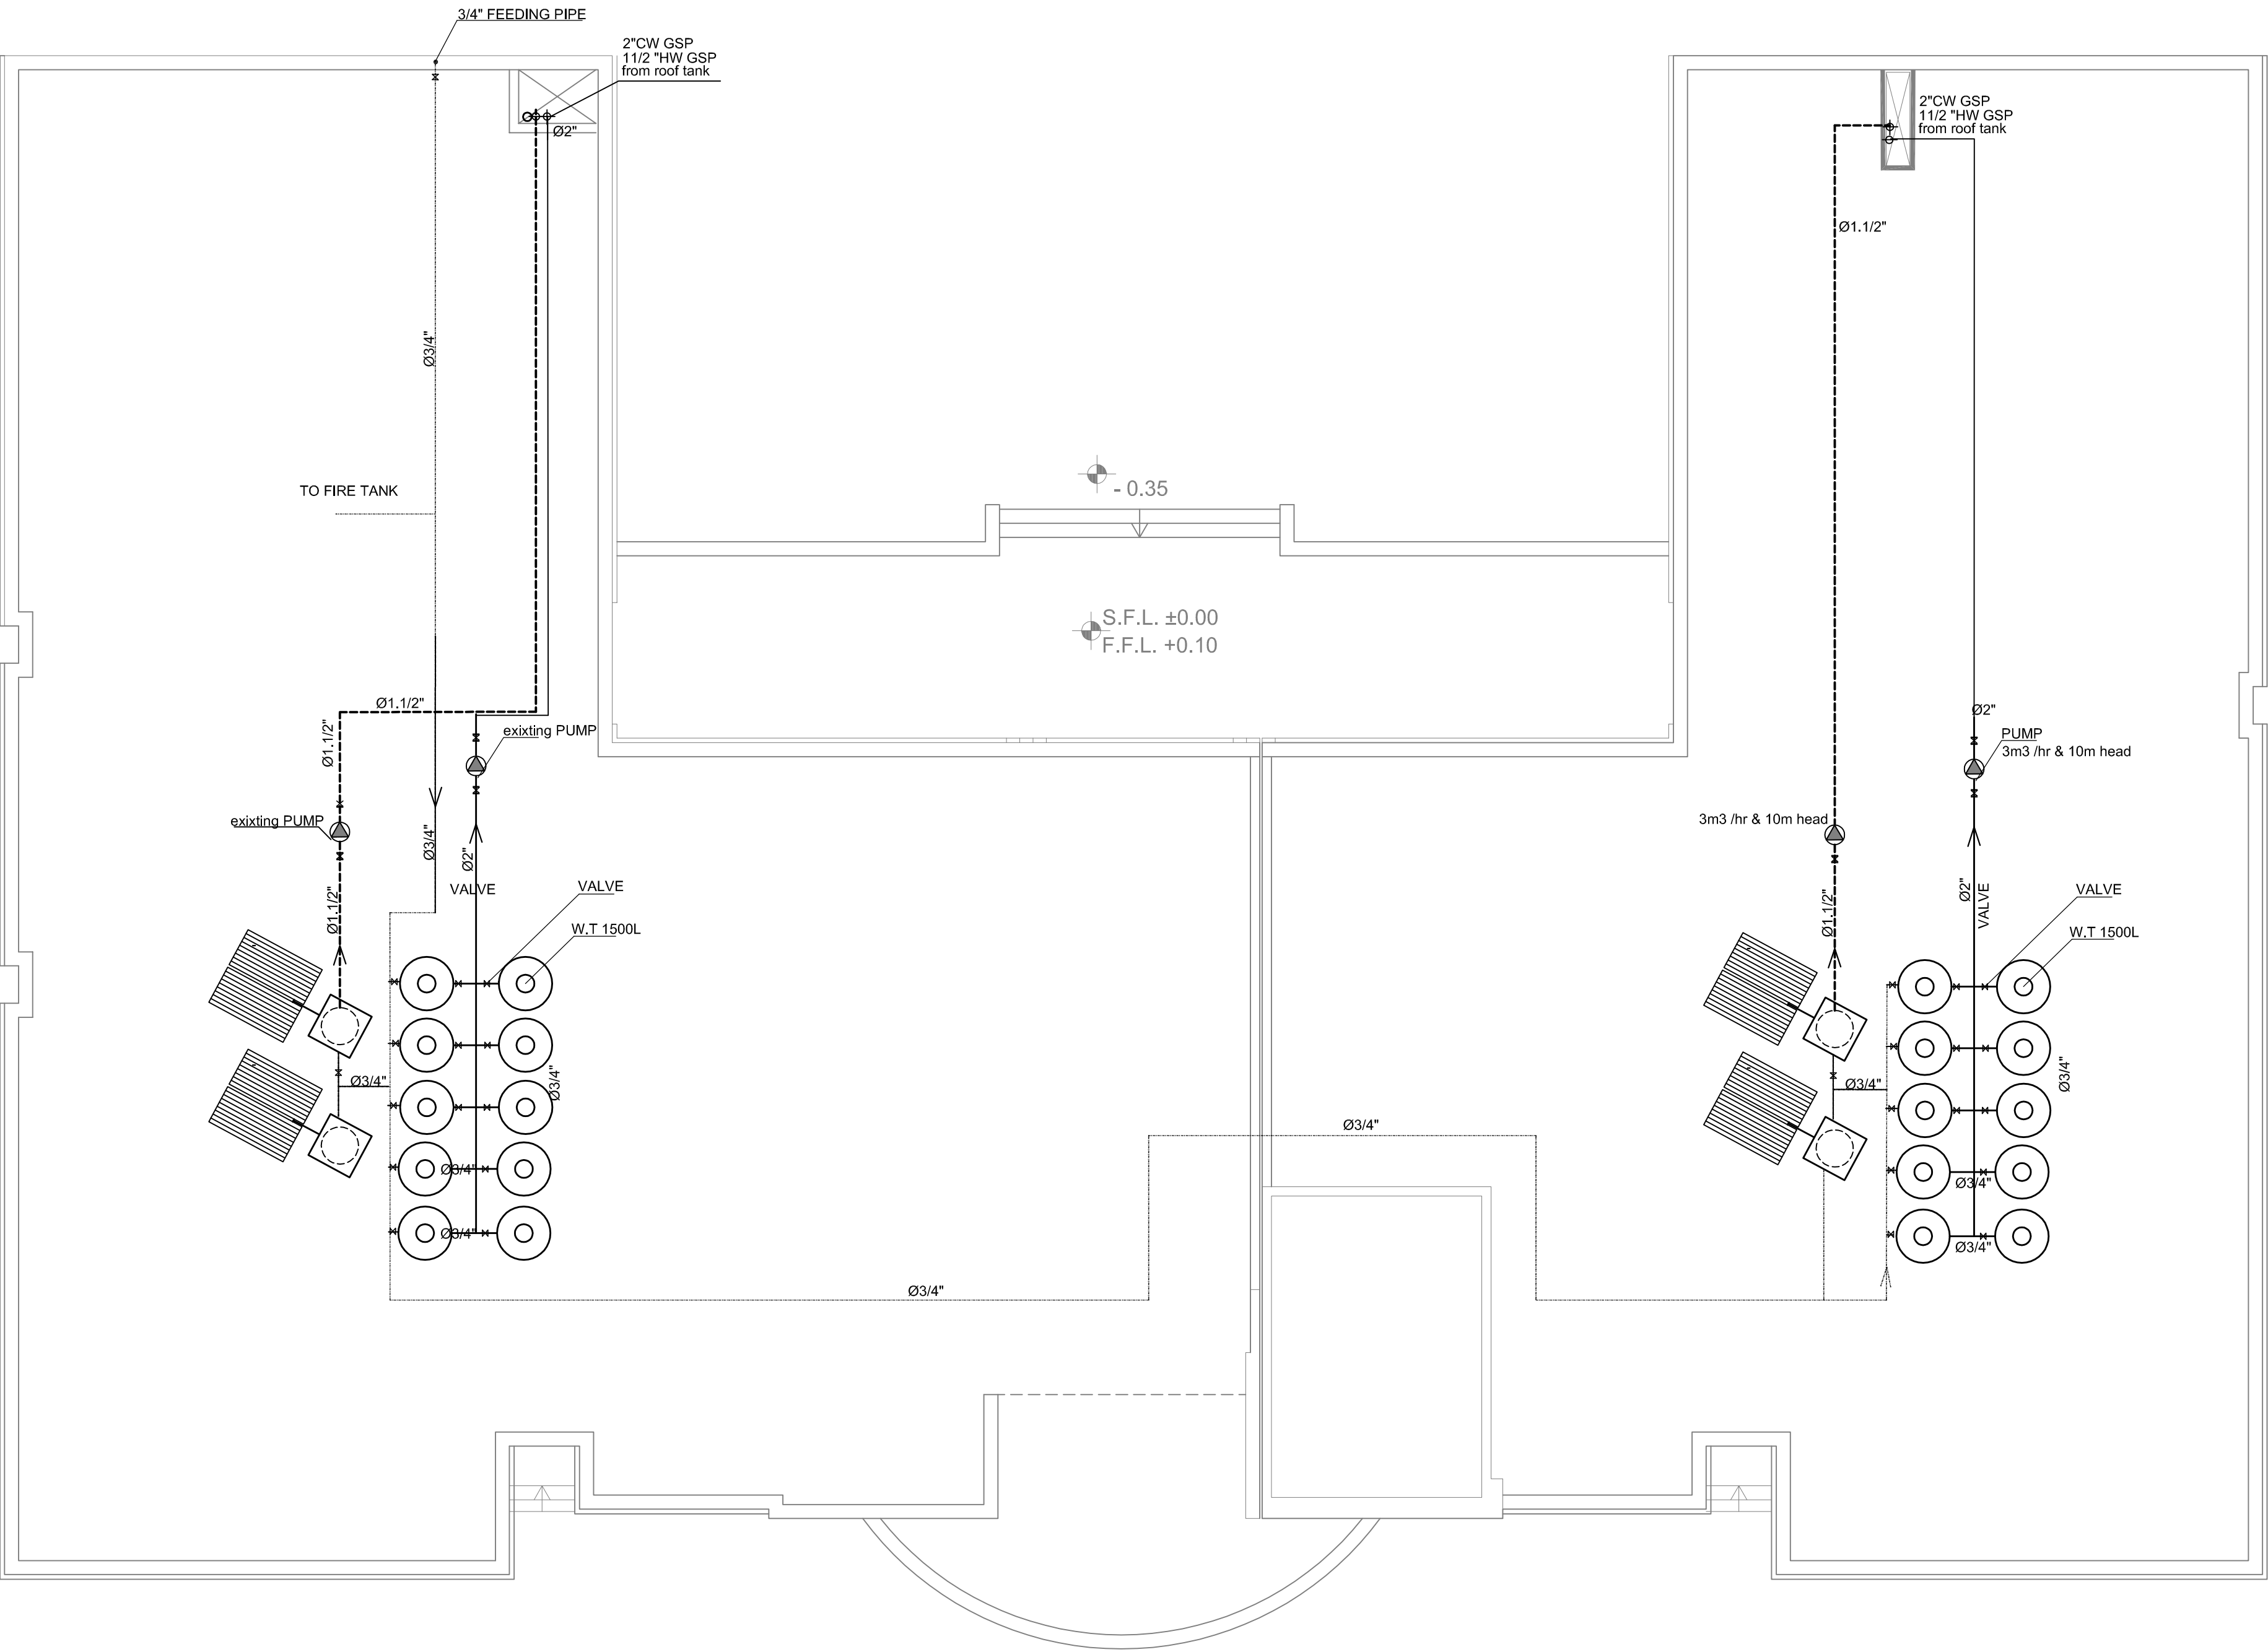

LEGEND

  - COLD WATER PIPE -----
- CITY WATER PIPE =====
- HOT WATER PIPE - - - - -
- 16MM PIPE (PEX) ~~~~~
- H&C WATER COLLECTOR 
- WATER METER 
- PUMP 
- ELEC. BOILER 80L 
- ELEC. BOILER 60L 
- NON RETERN VALVE 
- GALVANIZE STEEL PIPE • G.S.P
- WATER TANK 1500L 
- VALVE 
- WATER COOLER 

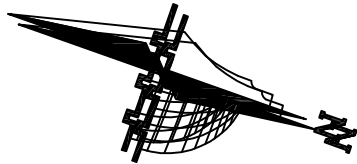


G.		
F.		
E.		
C.	THIRD REVISION	29/8/2018
B.	SECOND REVISION	7/8/2018
A.	FIRST REVISION	24/7/2018
Rev. No.	Rev. Description	Date




PIEFZA



UNDP

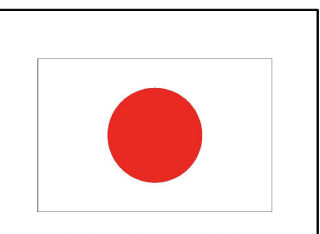

 من الشعب الياباني
From the People of Japan




AL AMEED
Architects & Engineers
NABLUS Tel. 09-2340472 / 2340610 Fax.09-2341302 P.o.Box 1112

PROJECT TITLE
Construction of Two Additional Floors to the Administration
Building at Jericho Agro-Industrial Park
JERICHO


DRAWING Title
**TOP ROOF FLOOR PLAN
WATER SUPPLY SYSTEM**

ARCHITECTURAL : NAHEEL YOUNES	
DRAWN : RANA HINDIA	
CHECKED : RAMI MALHIS	
APPROVED : RAMI MALHIS	
SCALE 1:100	DATE 9/ 2018
DRAWING NO. M-203	

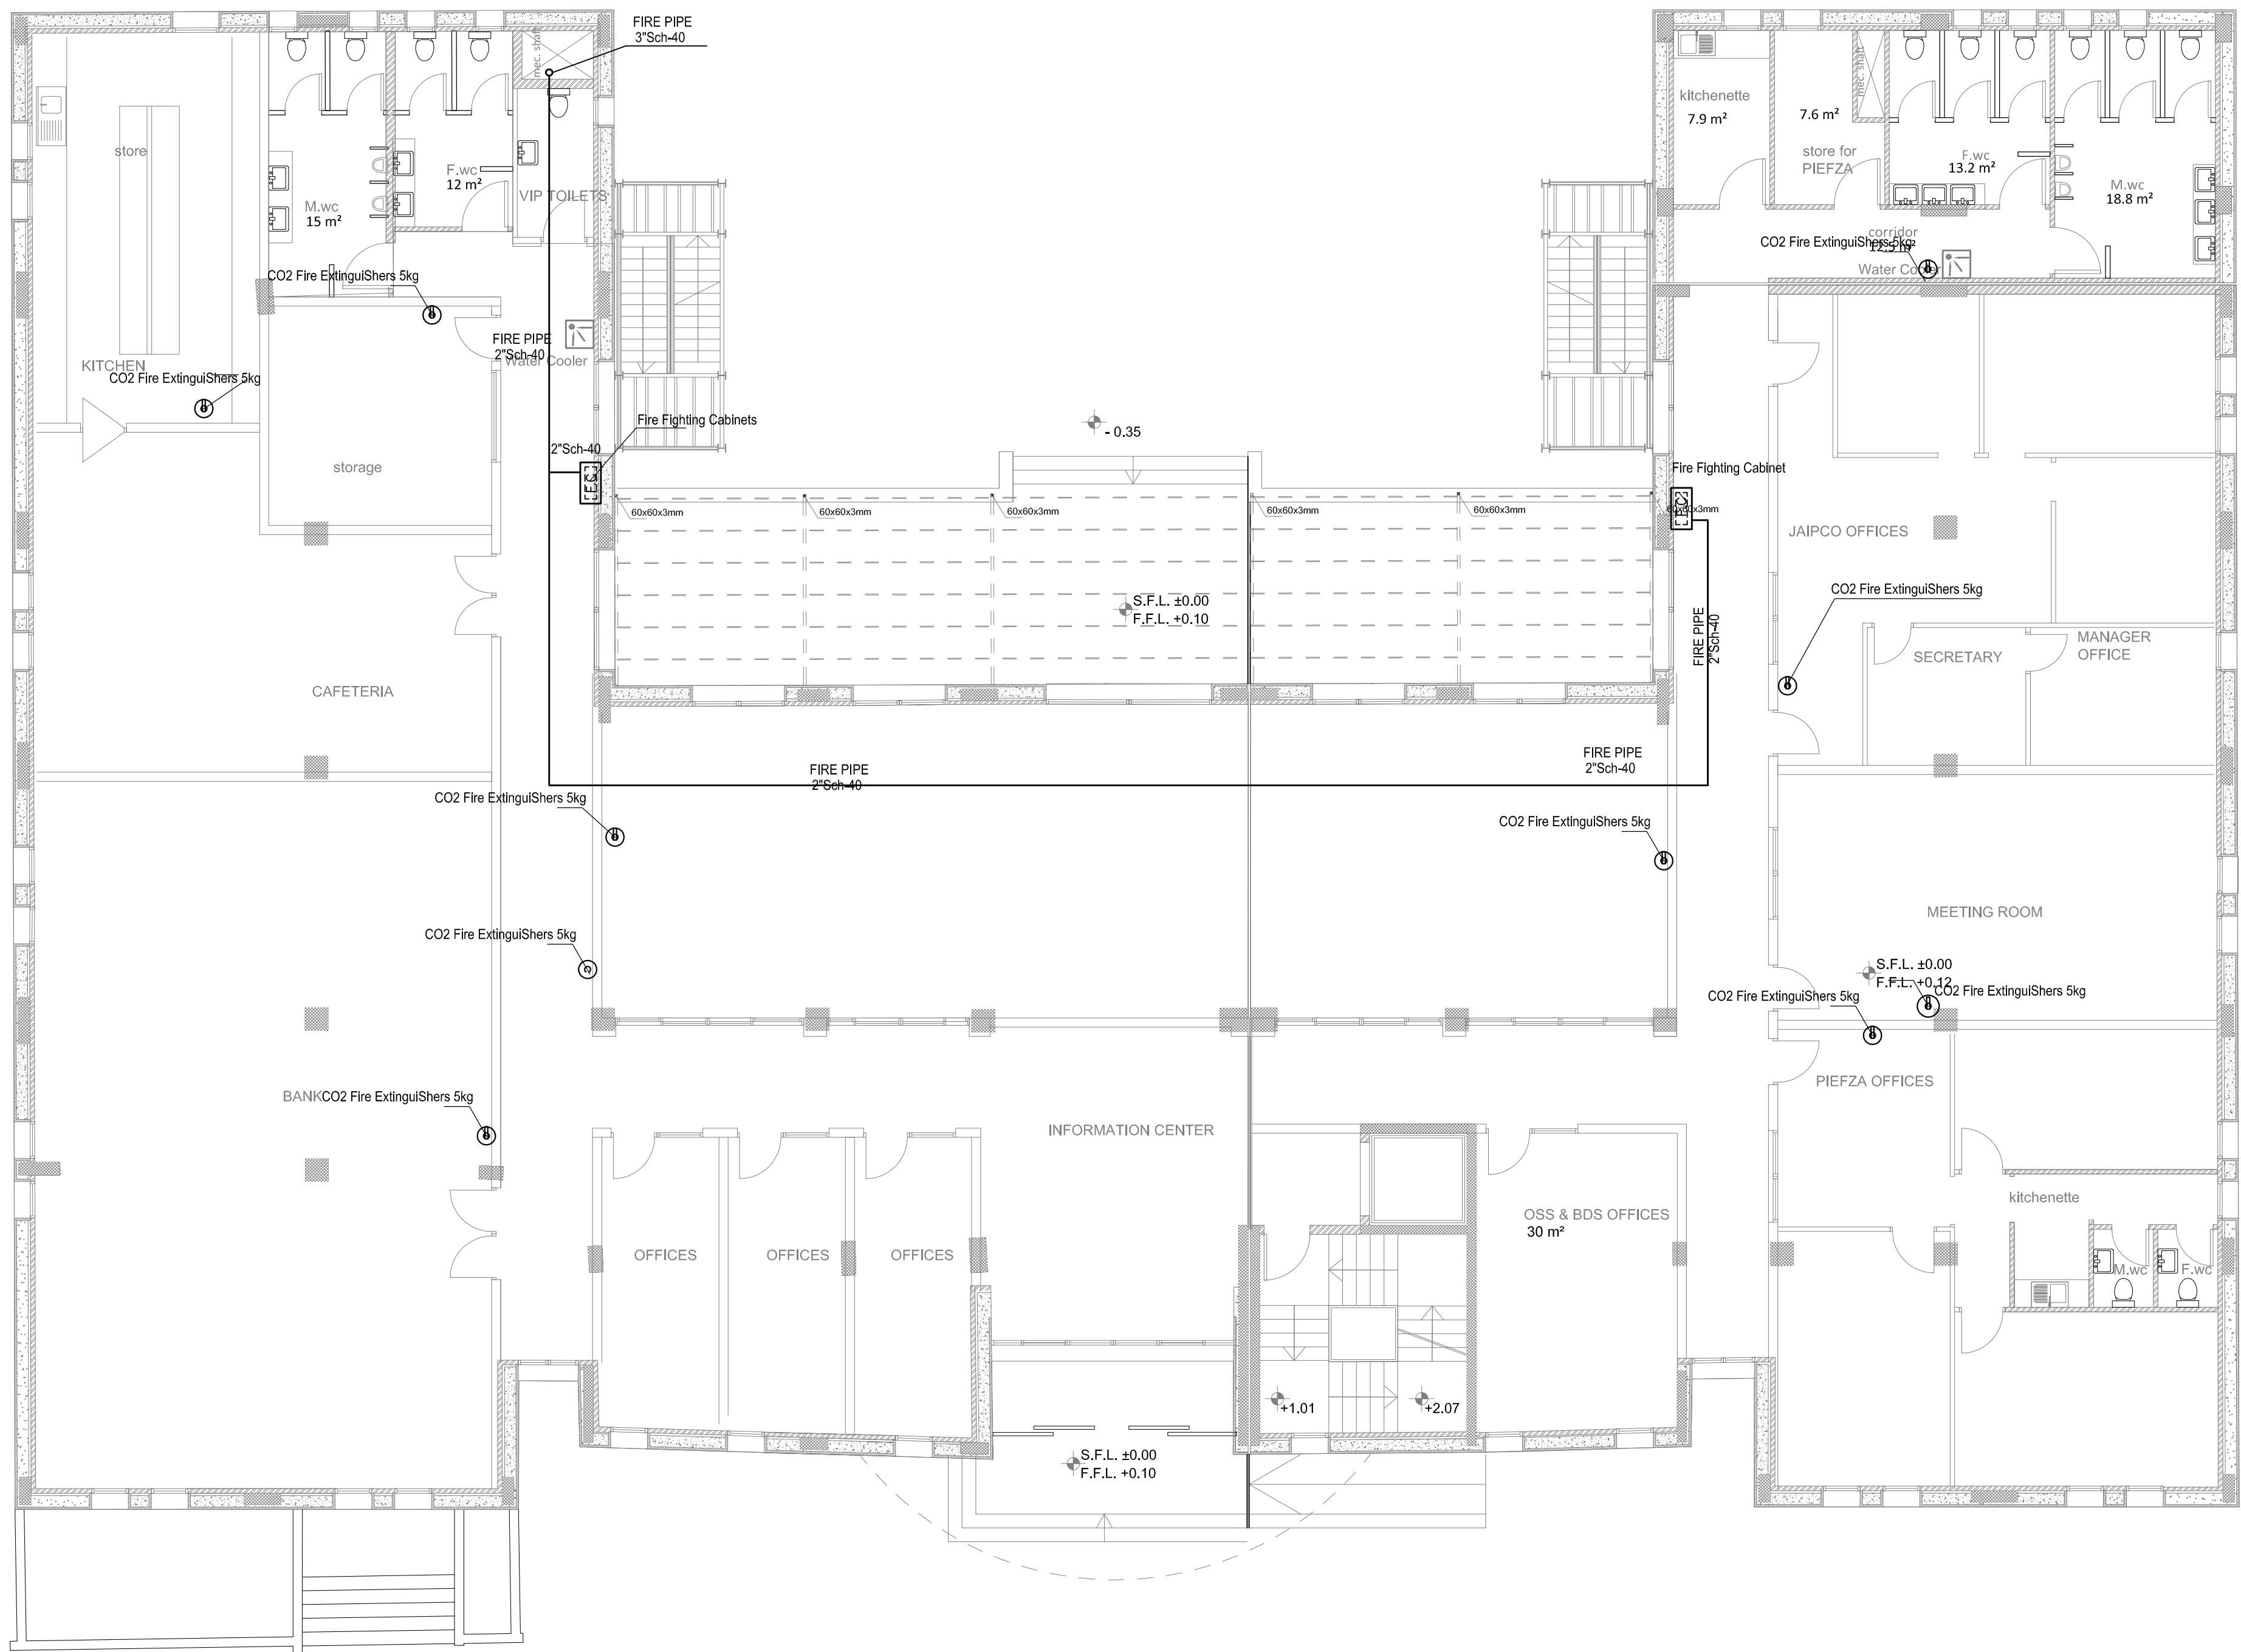

LEGEND:

- F.P
- FHC
- FIRE EXTINGUISHER 2KG CO2 TYPE
- FIRE PIPE
- FIRE HOSE REEL CABINET
- FROM ABOVE
- FROM BELOW
- T/B
- FIRE EXTINGUISHER 3 KG POWDER
- SPRINKLER
- SIAMESE CONNECTION

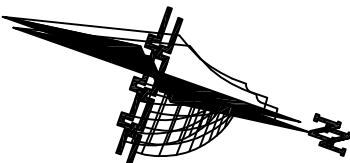

G.		
F.		
E.		
C.	THIRD REVISION	29/8/2018
B.	SECOND REVISION	7/8/2018
A.	FIRST REVISION	24/7/2018
Rev. No.	Rev. Description	Date




AL AMEED
Architects & Engineers
NABLUS Tel. 09-2340472 / 2340610 Fax:09-2341302 P.o.Box 1112



PROJECT TITLE
Construction of Two Additional Floors to the Administration
Building at Jericho Agro-Industrial Park
JERICHO


DRAWING Title
**GROUND FLOOR PLAN
FIRE FIGHTING SYSTEM**

ARCHITECTURAL : NAHEEL YOUNES	
DRAWN : RANA HINDIA	
CHECKED : RAMI MALHIS	
APPROVED : RAMI MALHIS	
SCALE 1:100	DATE 9/ 2018
DRAWING NO. M-300	

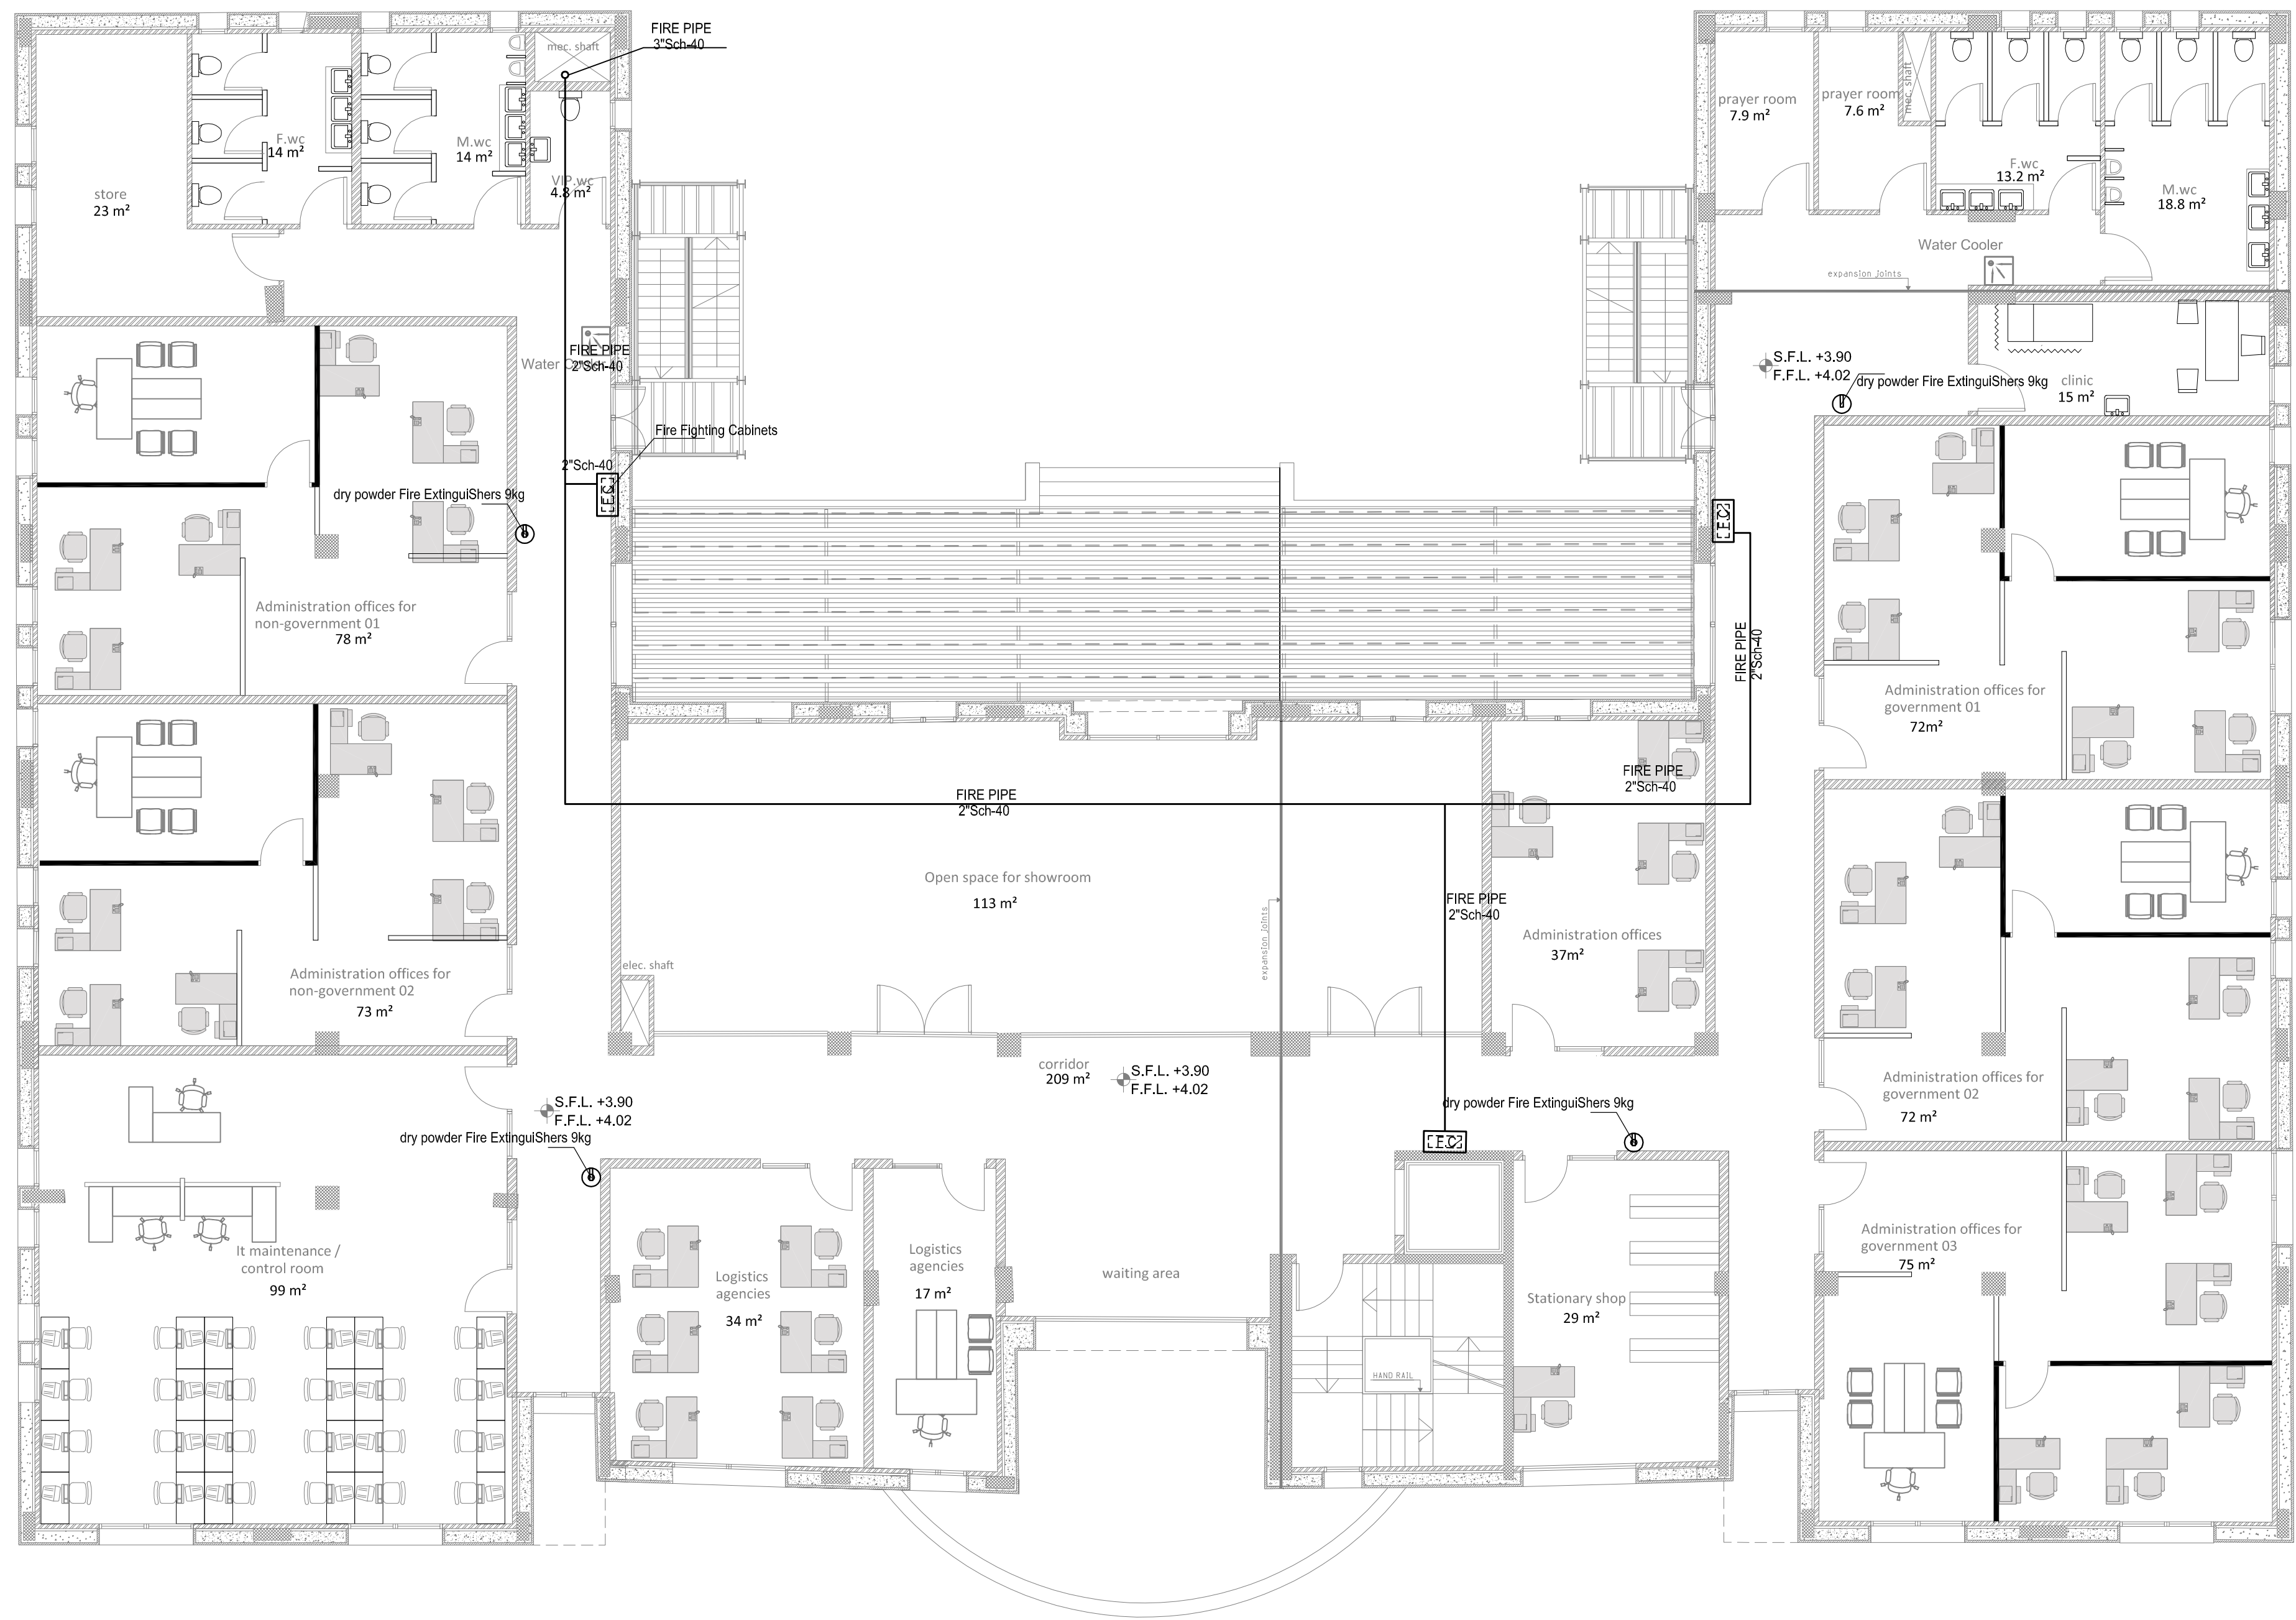


LEGEND:

  - F.P
-  FHC
-  FIRE EXTINGUISHER 2KG CO2 TYPE
- F.P FIRE PIPE
- FHC FIRE HOSE REEL CABINET
- F/A FROM ABOVE
- F/B FROM BELOW
- T/B TO BELOW
-  FIRE EXTINGUISHER 3 KG POWDER
-  SPRINKLER
-  SIAMESE CONNECTION

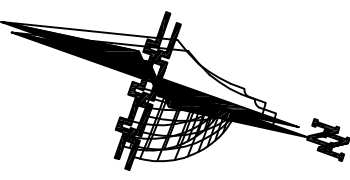


G.		
F.		
E.		
C.	THIRD REVISION	29/8/2018
B.	SECOND REVISION	7/8/2018
A.	FIRST REVISION	24/7/2018
Rev. No.	Rev. Description	Date

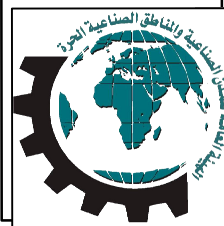

PIEFA



UNDP

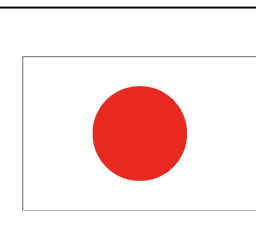

من الشعب الياباني
From the People of Japan




AL AMEED
Architects & Engineers
NABLUS Tel. 09-2340472 / 2340610 Fax.09-2341302 P.o.Box 1112

PROJECT TITLE
Construction of Two Additional Floors to the Administration Building at Jericho Agro-Industrial Park
JERICHO


DRAWING Title
FIRST FLOOR PLAN
FIRE FIGHTING SYSTEM

ARCHITECTURAL : NAHEEL YOUNES	
DRAWN : RANA HINDIA	
CHECKED : RAMI MALHIS	
APPROVED : RAMI MALHIS	
SCALE 1:100	DATE 9/ 2018
DRAWING NO. M-301	

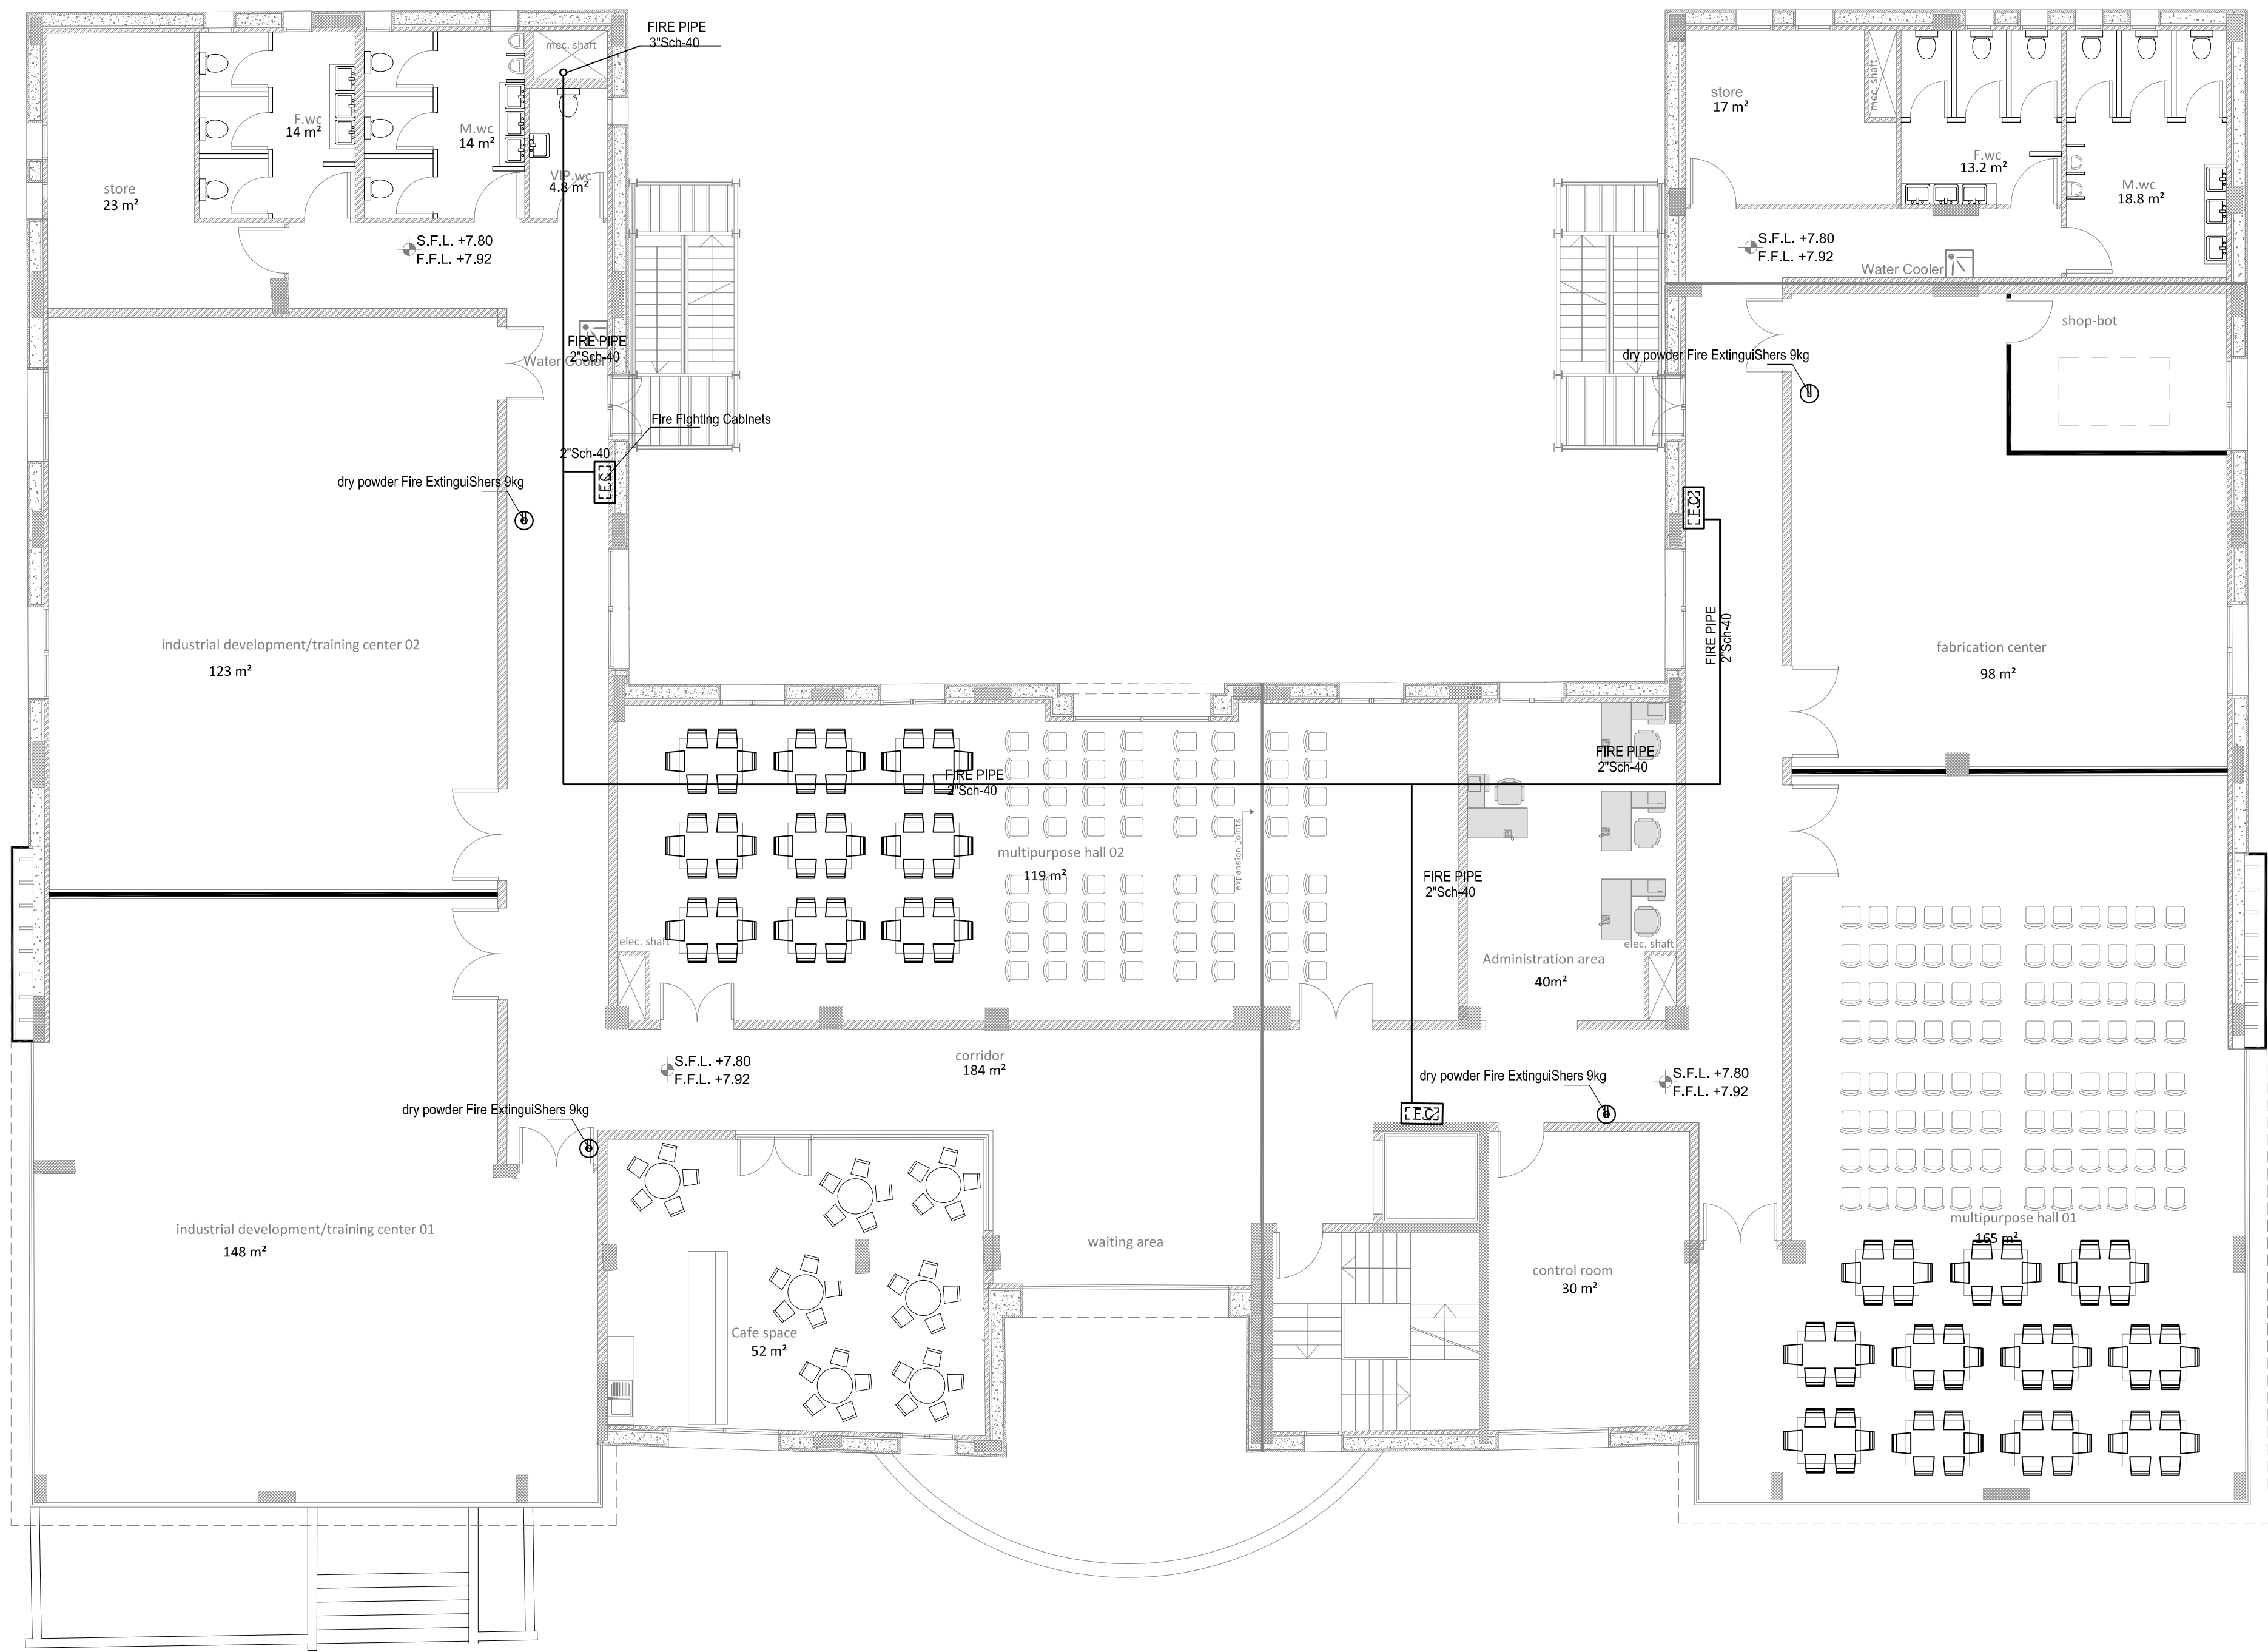

LEGEND:

- F.P
FHC
F.P
FHC
F/A
F/B
T/B
FIRE EXTINGUISHER
2KG CO2 TYPE
FIRE PIPE
FIRE HOSE REEL CABINET
FROM ABOVE
TO BELOW
FIRE EXTINGUISHER
3 KG POWDER
SPRINKLER
SIAMESE CONNECTION

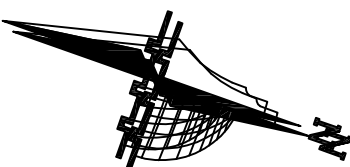


G.		
F.		
E.		
C.	THIRD REVISION	29/8/2018
B.	SECOND REVISION	7/8/2018
A.	FIRST REVISION	24/7/2018
Rev. No.	Rev. Description	Date




PIEFZA



UNDP

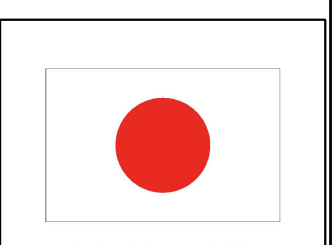

 من الشعب الياباني
From the People of Japan




AL AMEED
Architects & Engineers
NABLUS Tel. 09-2340472 / 2340610 Fax 09-2341302 P.o.Box 1112




PROJECT TITLE
Construction of Two Additional Floors to the Administration
Building at Jericho Agro-Industrial Park
JERICHO


DRAWING Title
SECOND FLOOR PLAN
FIRE FIGHTING SYSTEM

ARCHITECTURAL : NAHEEL YOUNES	
DRAWN : RANA HINDIA	
CHECKED : RAMI MALHIS	
APPROVED : RAMI MALHIS	
SCALE 1:100	DATE 9/ 2018
DRAWING NO. M-302	

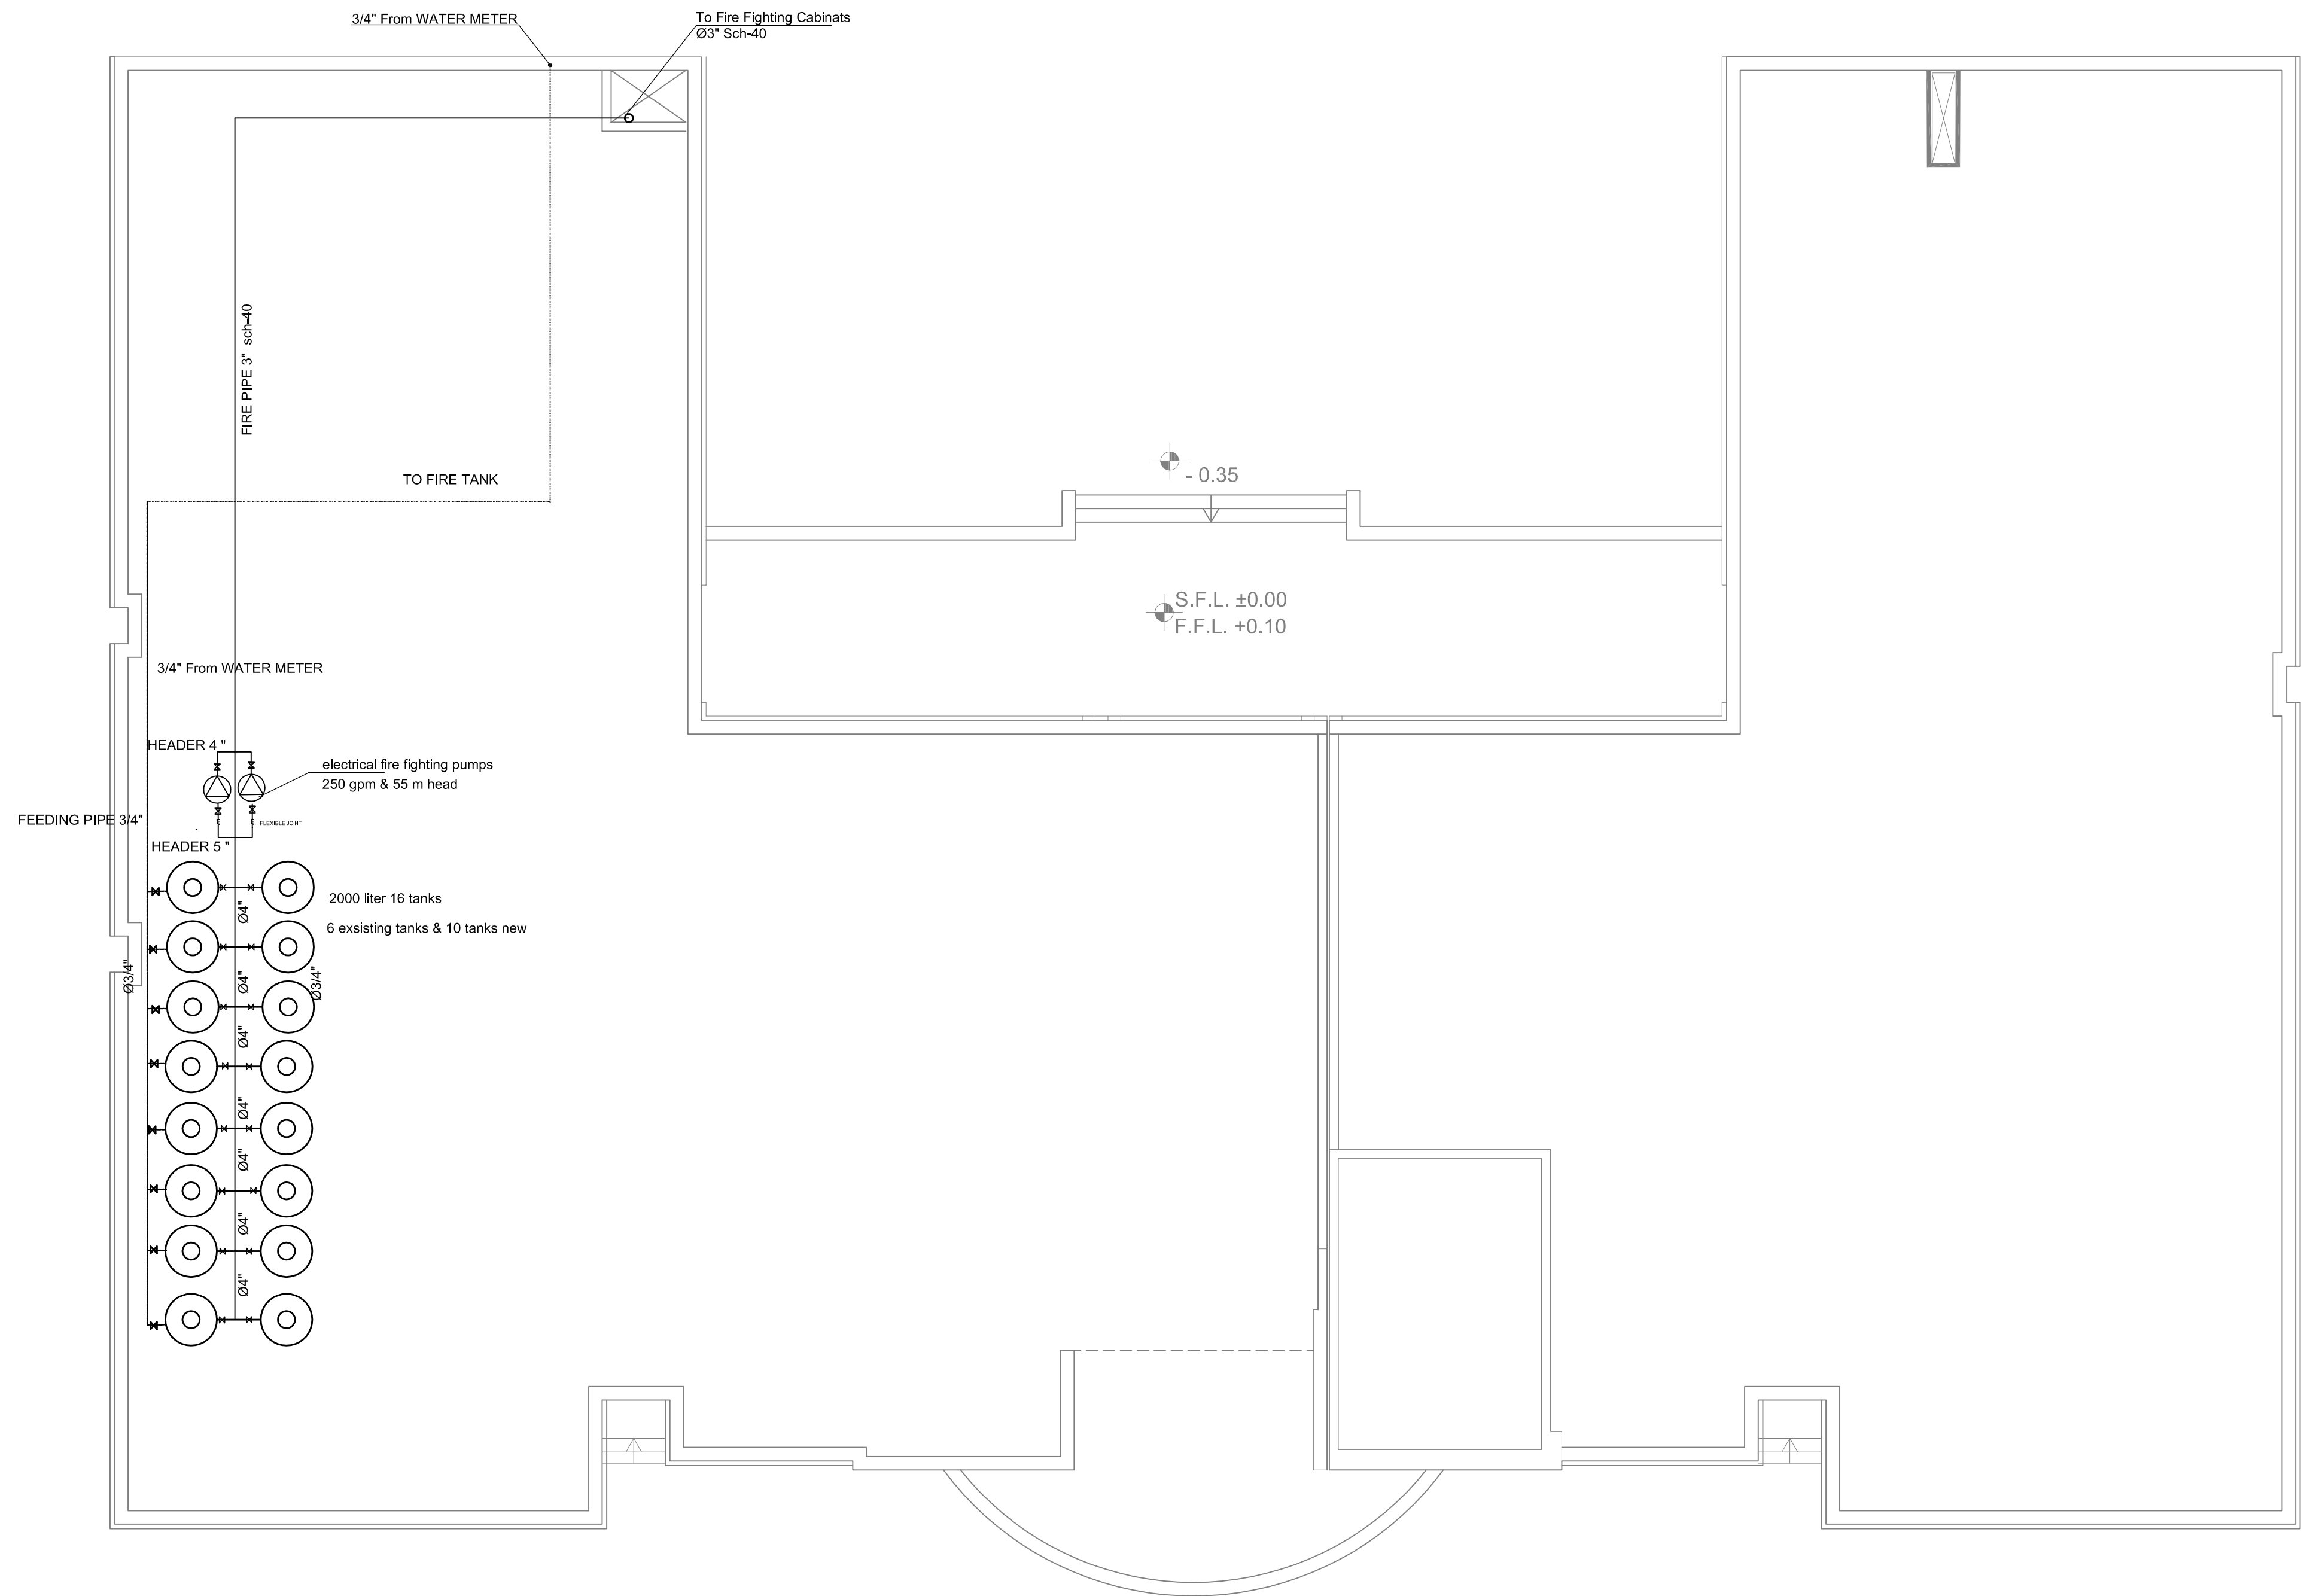

LEGEND:

   
- F.P
-  FHC
-  FIRE EXTINGUISHER
2KG CO2 TYPE
- F.P FIRE PIPE
- FHC FIRE HOSE REEL CABINET
- F/A FROM ABOVE
- F/B FROM BELOW
- T/B TO BELOW
-  FIRE EXTINGUISHER
3 KG POWDER
-  SPRINKLER
-  SIAMESE CONNECTION

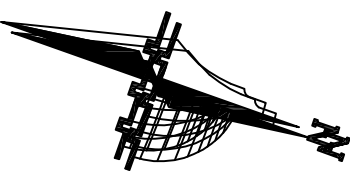


G.		
F.		
E.		
C.	THIRD REVISION	29/8/2018
B.	SECOND REVISION	7/8/2018
A.	FIRST REVISION	24/7/2018
Rev. No.	Rev. Description	Date


PIEFZA


UNDP

 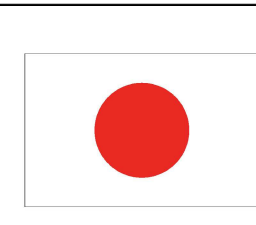
من الشعب الياباني
From the People of Japan


AL AMEED
Architects & Engineers
NABLUS Tel. 09-2340472 / 2340610 Fax.09-2341302 P.o.Box 1112

PROJECT TITLE
Construction of Two Additional Floors to the Administration
Building at Jericho Agro-Industrial Park
JERICHO

DRAWING Title
TOP ROOF FLOOR PLAN
FIRE FIGHTING SYSTEM

ARCHITECTURAL : NAHEEL YOUNES	
DRAWN : RANA HINDIA	
CHECKED : RAMI MALHIS	
APPROVED : RAMI MALHIS	
SCALE 1:100	DATE 9/ 2018
	DRAWING NO. M-303