

State Liaison Functions (SLF) - Joint

Prototype Police Training Center



Empowered lives.
Resilient nations.


January 2019



Bahauddin Ibrahim
ENGINEERING

Project Management | Design | Supervision

+249 9 123 3 1958

bahauddin.engineering@gmail.com

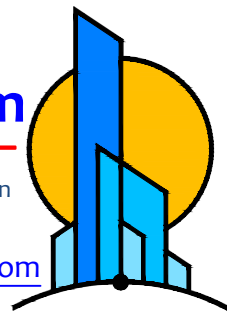

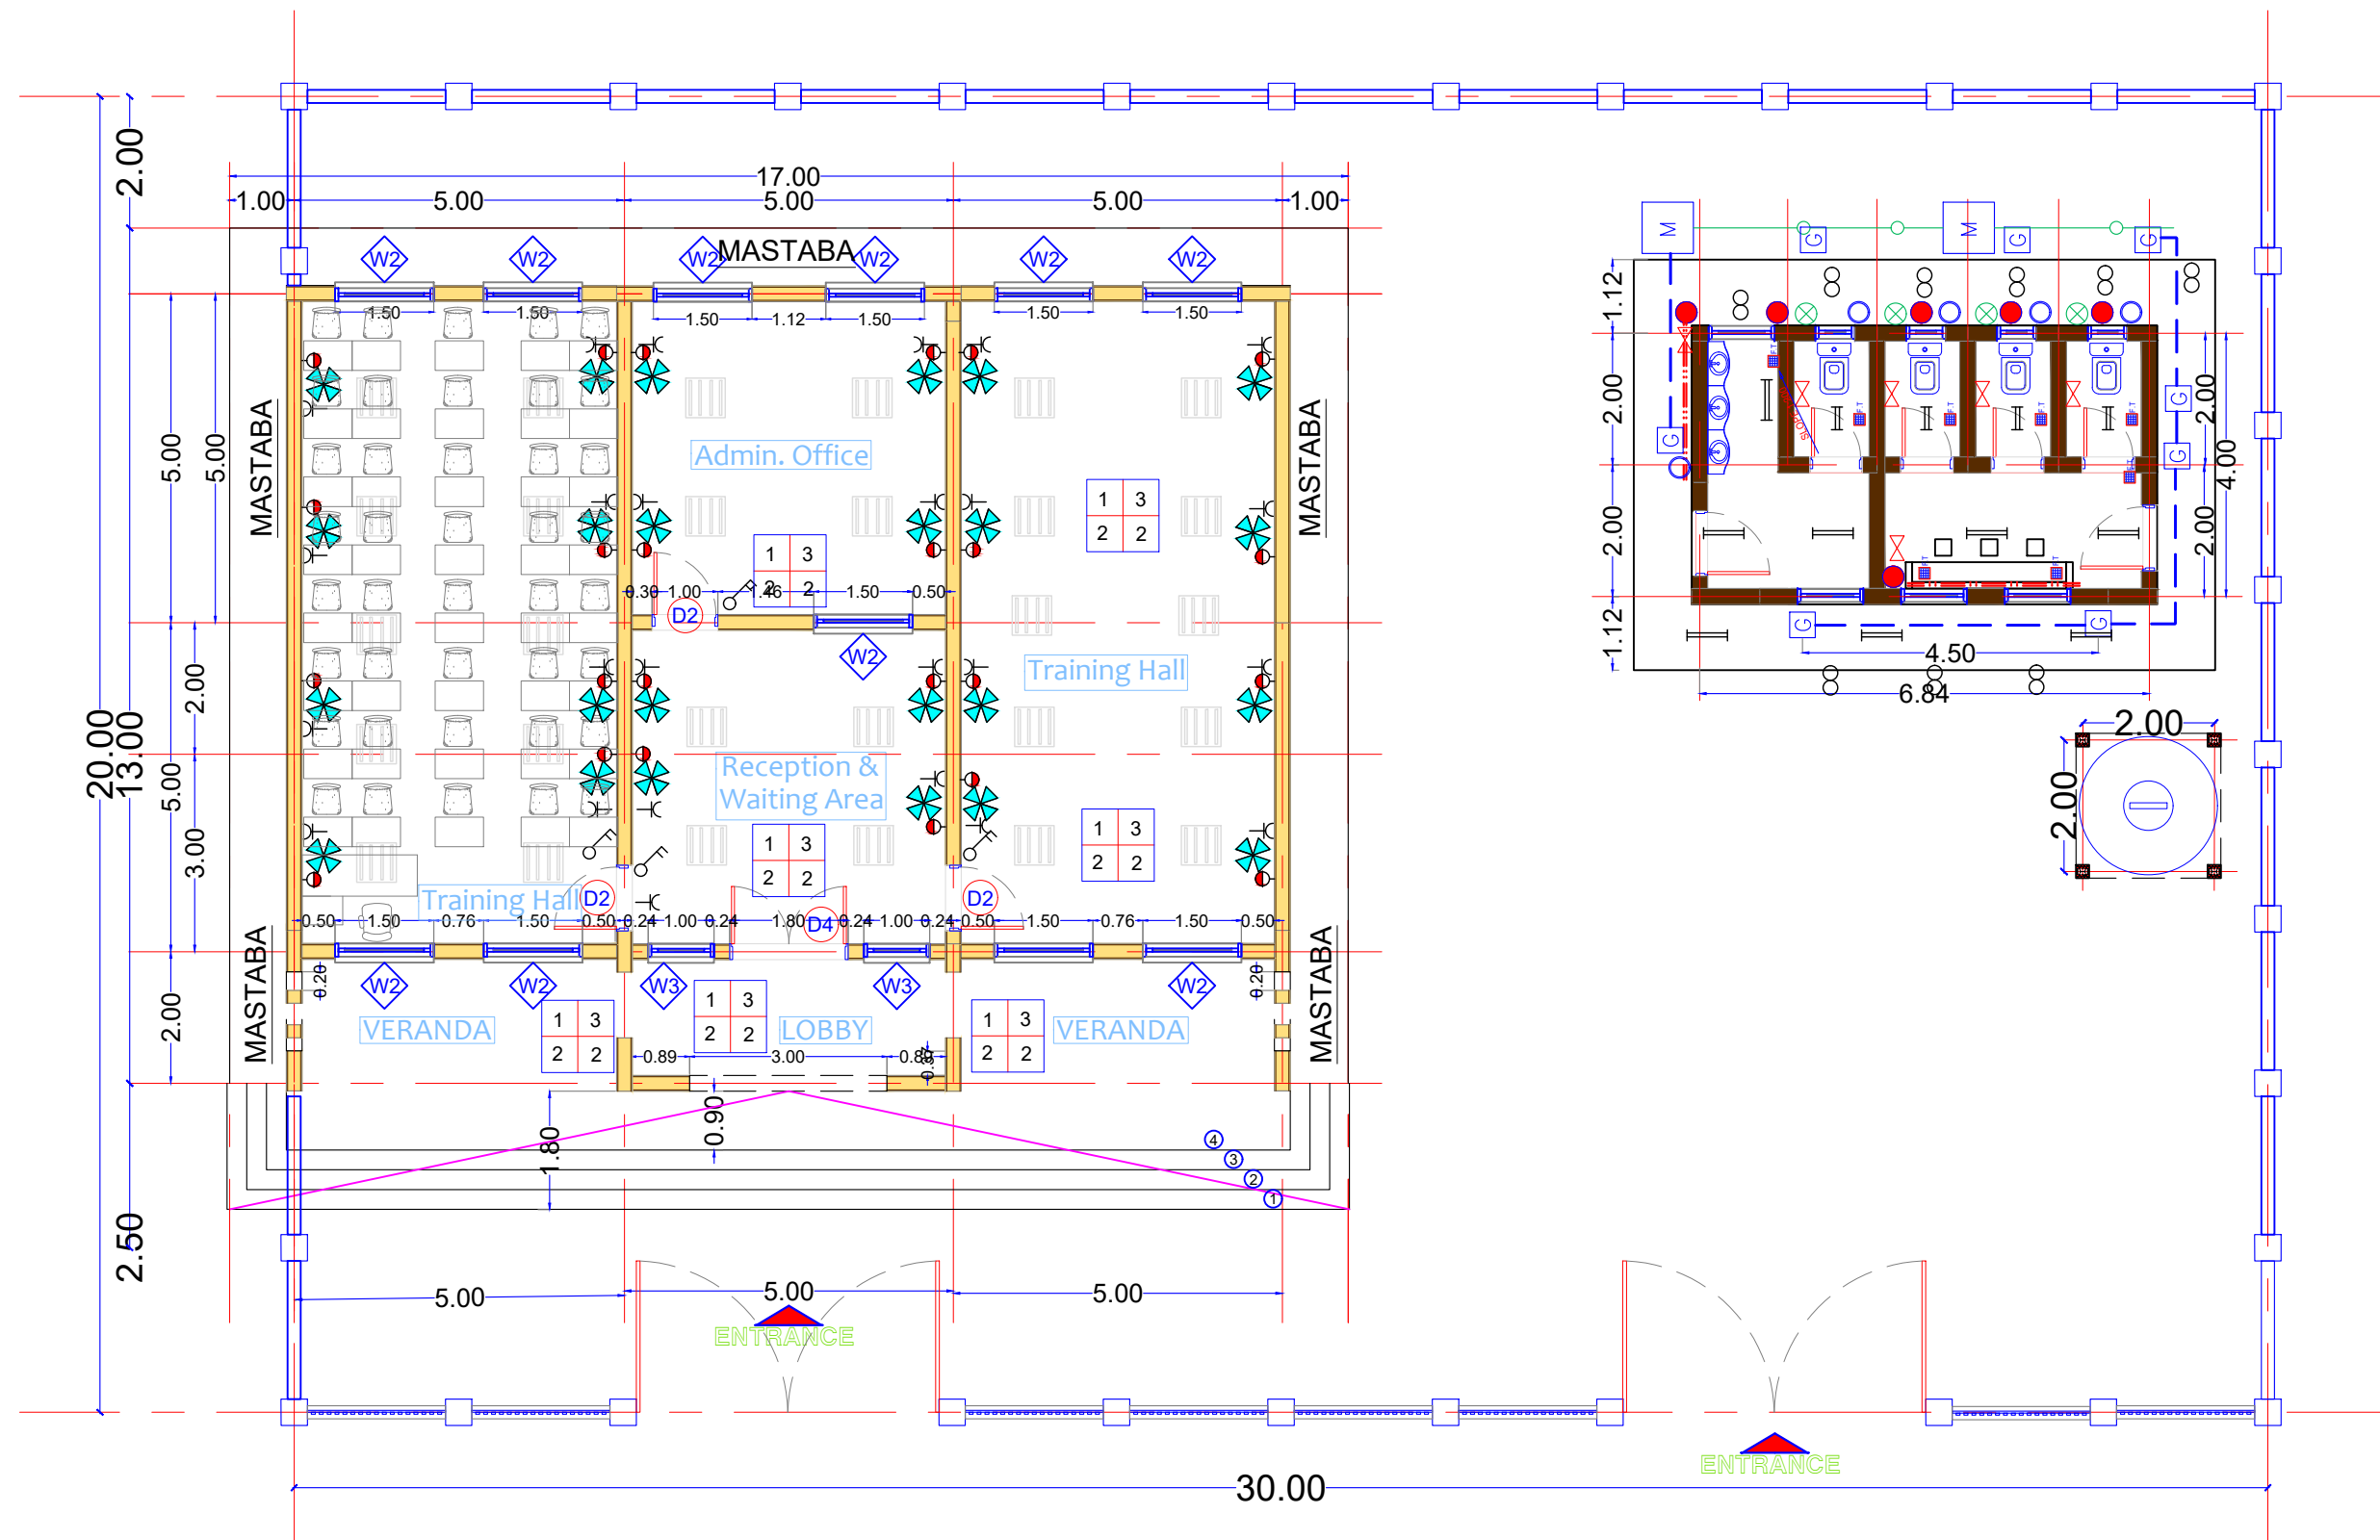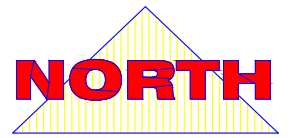

GENERAL LAYOUT
MASTER PLAN
Scale NTSA3



Lead Agency:
UNDP
UNAMID
State Liaison Functions (SLF)

Design by:
Bahauddin Ibrahim
ENGINEERING
Project Management | Design | Supervision
+249 9 123 3 1958
bahauddin.engineering@gmail.com

Master Plan

December
2018

A0

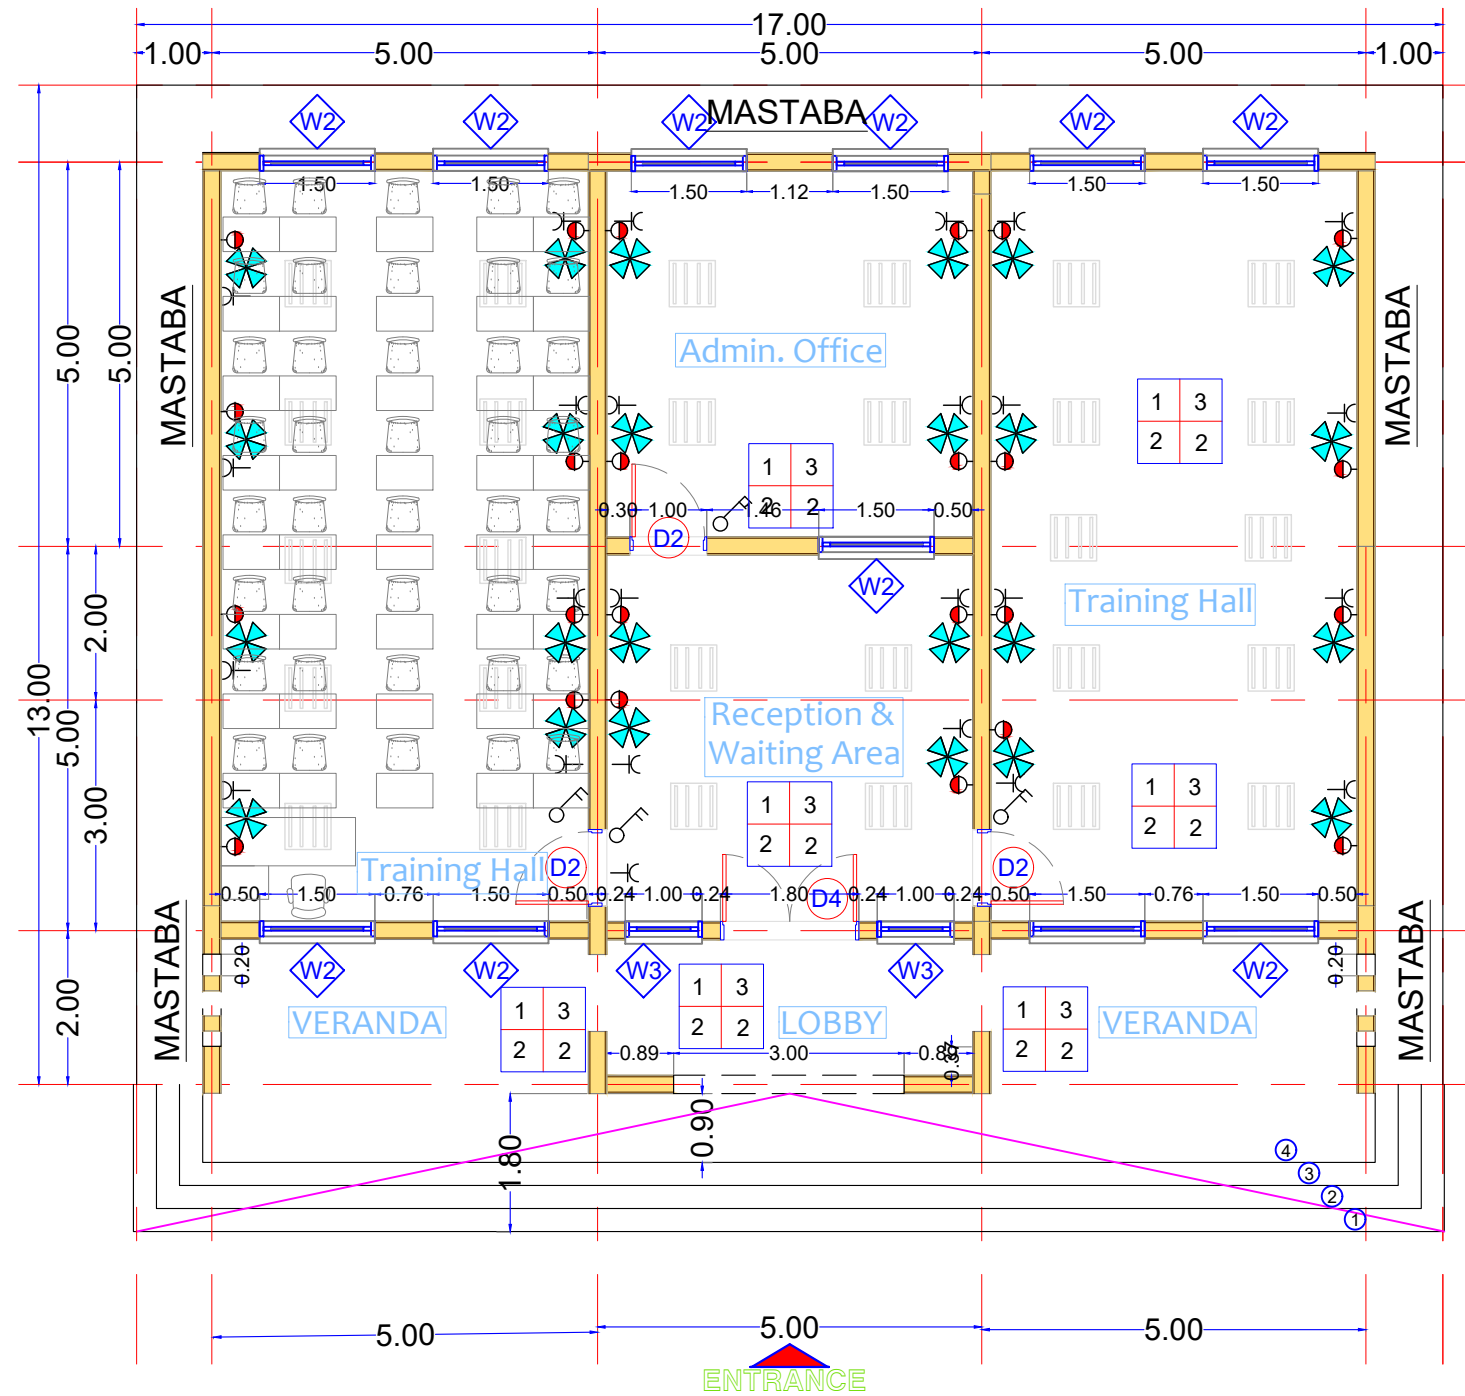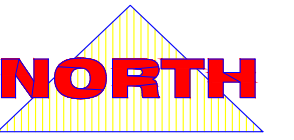

ELECTRICAL LAYOUT
Main Building

Scale 1:100 A3



Lead Agency:
UNDP
UNAMID
State Liaison Functions (SLF)

Design by:
Bahauddin Ibrahim
ENGINEERING
Project Management | Design | Supervision
+249 9 123 3 1958
bahauddin.engineering@gmail.com

Detailed Plans

December
2018

A1

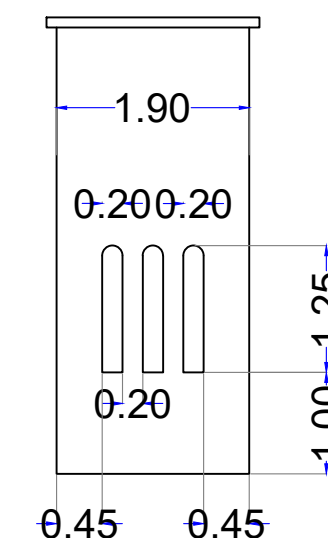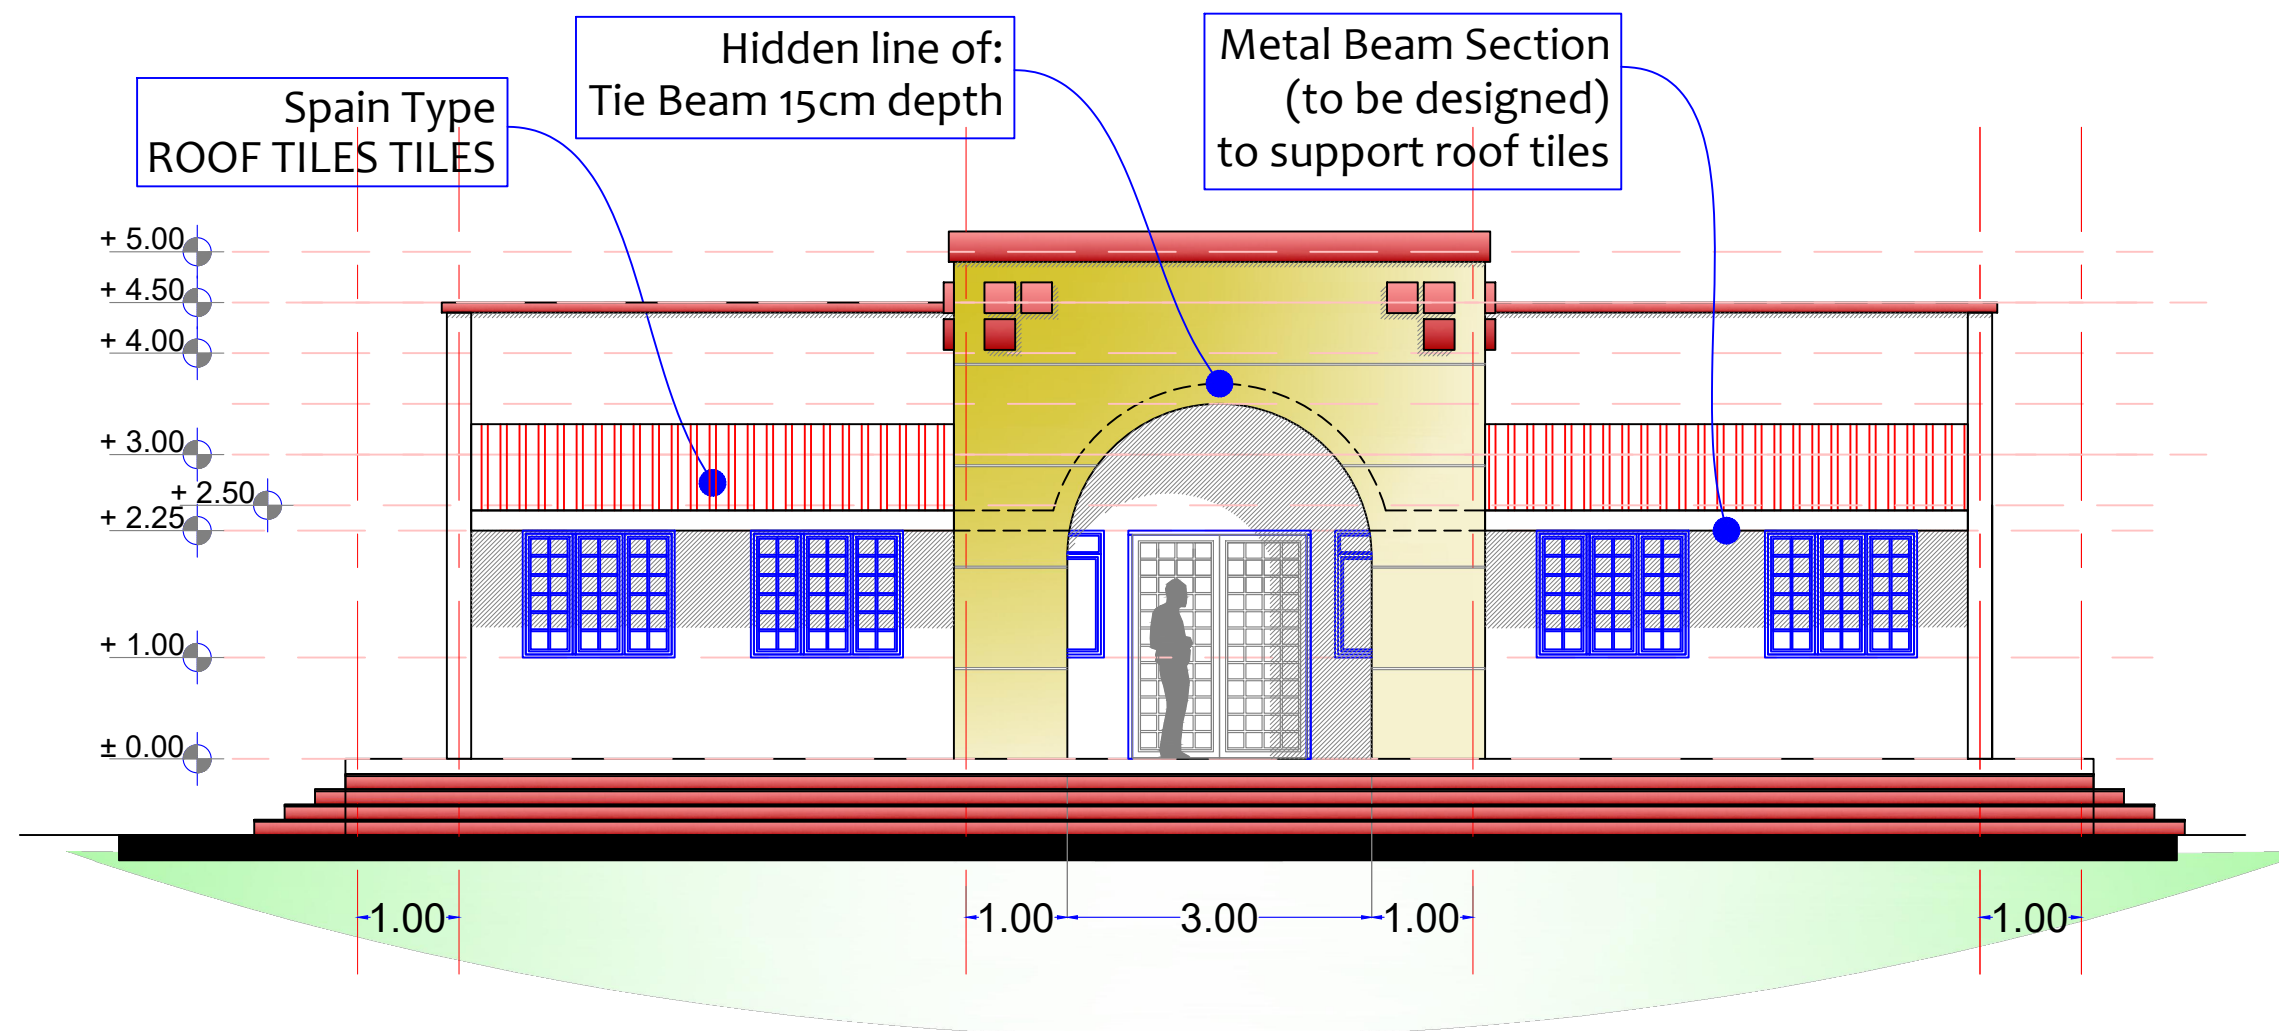

ELEVATION MAIN VIEW
Main Building


Lead Agency:
UNDP
UNAMID
State Liaison Functions (SLF)
Joint Program

Design by:
Bahauddin Ibrahim
ENGINEERING
Project Management | Design | Supervision
+249 9 123 3 1958
bahauddin.engineering@gmail.com

ELEVATION

2019

A2

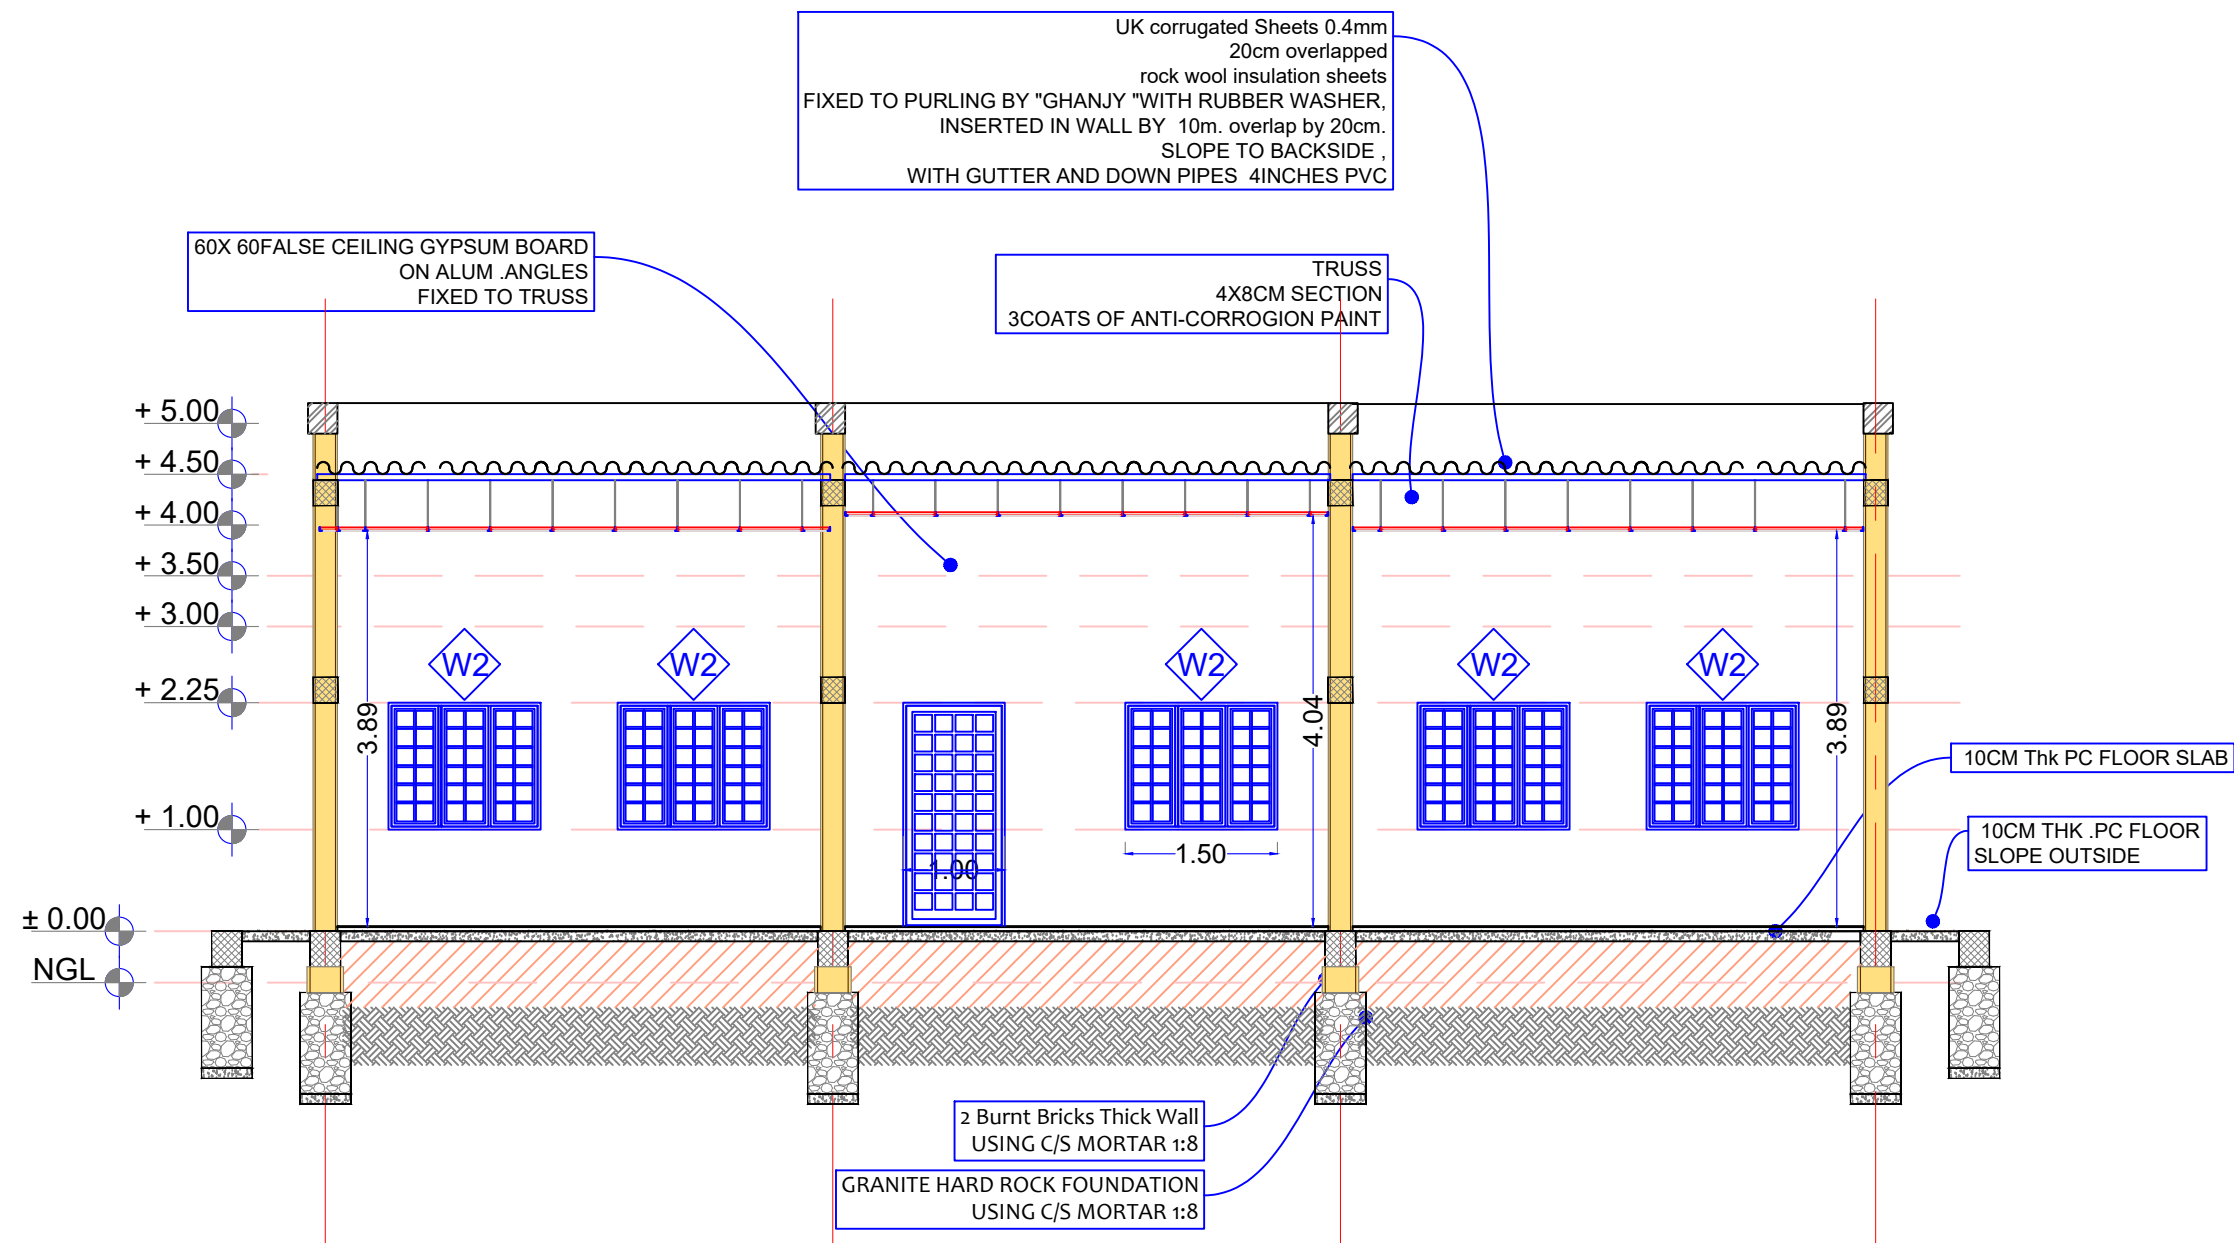

MAIN OFFICES DETAILED SECTION (AA)

Lead Agency:

UNDP
UNAMID

State Liaison Functions (SLF)
Joint Program

Design by:

Bahauddin Ibrahim
ENGINEERING

Project Management | Design | Supervision

+249 9 123 3 1958


bahauddin.engineering@gmail.com




SECTION

2019

A3

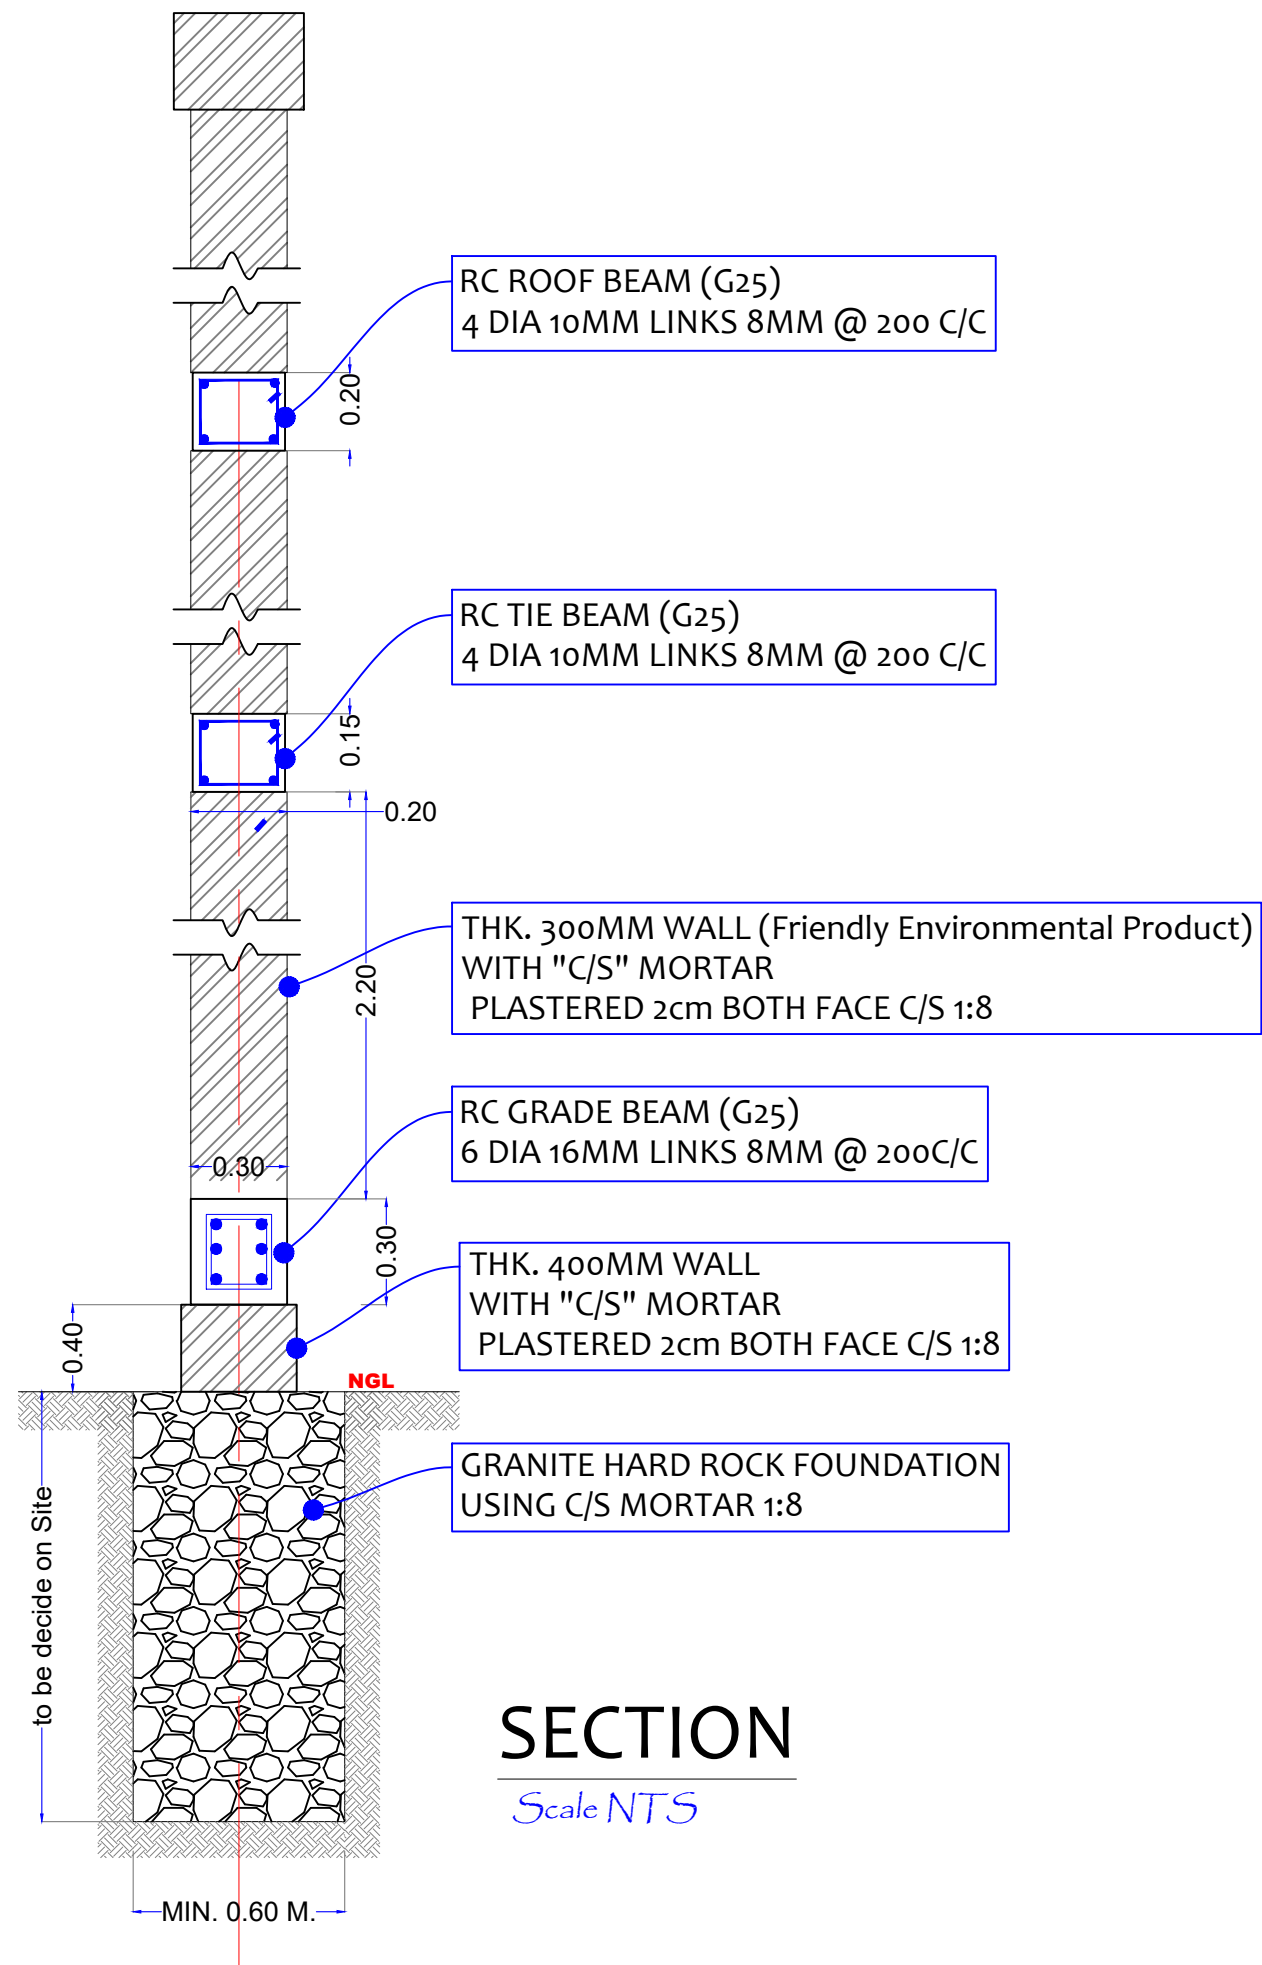

SECTION
Scale NTS

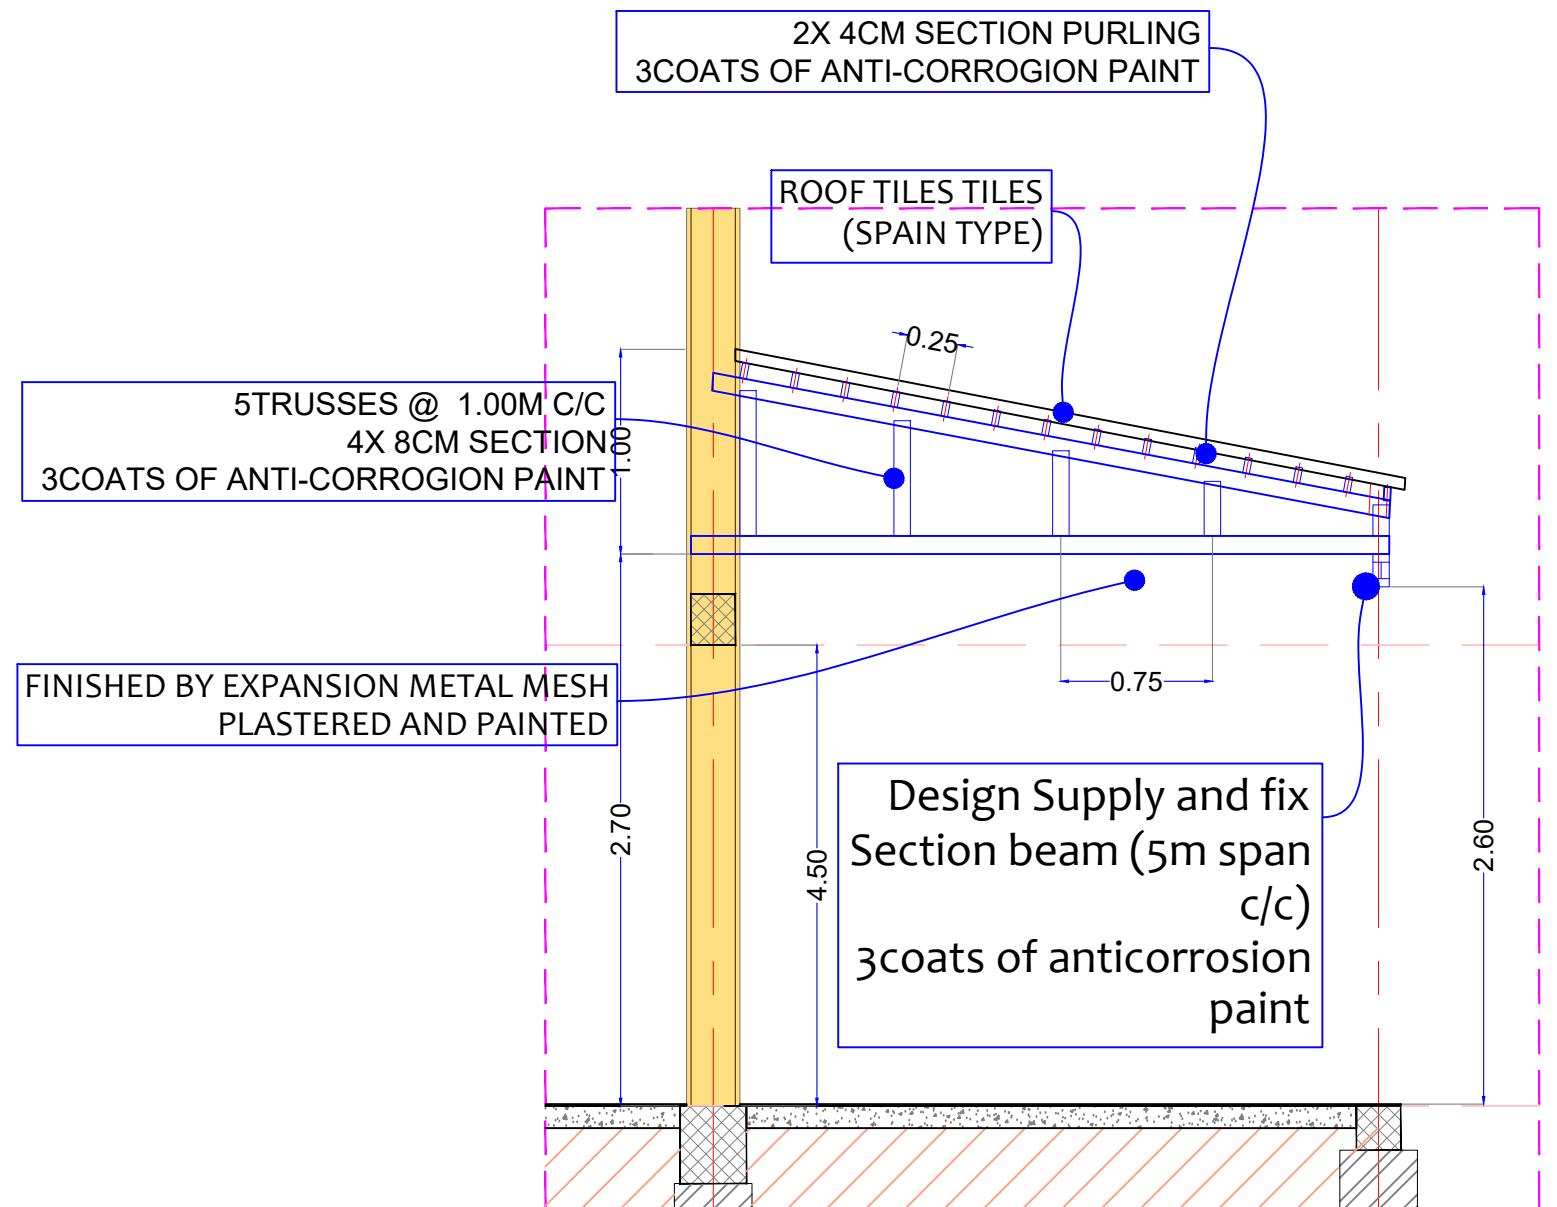

VERANDA SECTION
Scale NTS

Lead Agency:
UNDP
UNAMID
State Liaison Functions (SLF)
Joint Program


Design by:
Bahauddin Ibrahim
ENGINEERING
Project Management | Design | Supervision
+249 9 123 3 1958
bahauddin.engineering@gmail.com

SECTION

2019

A4

ELEVATION MAIN VIEW
Main Entrance

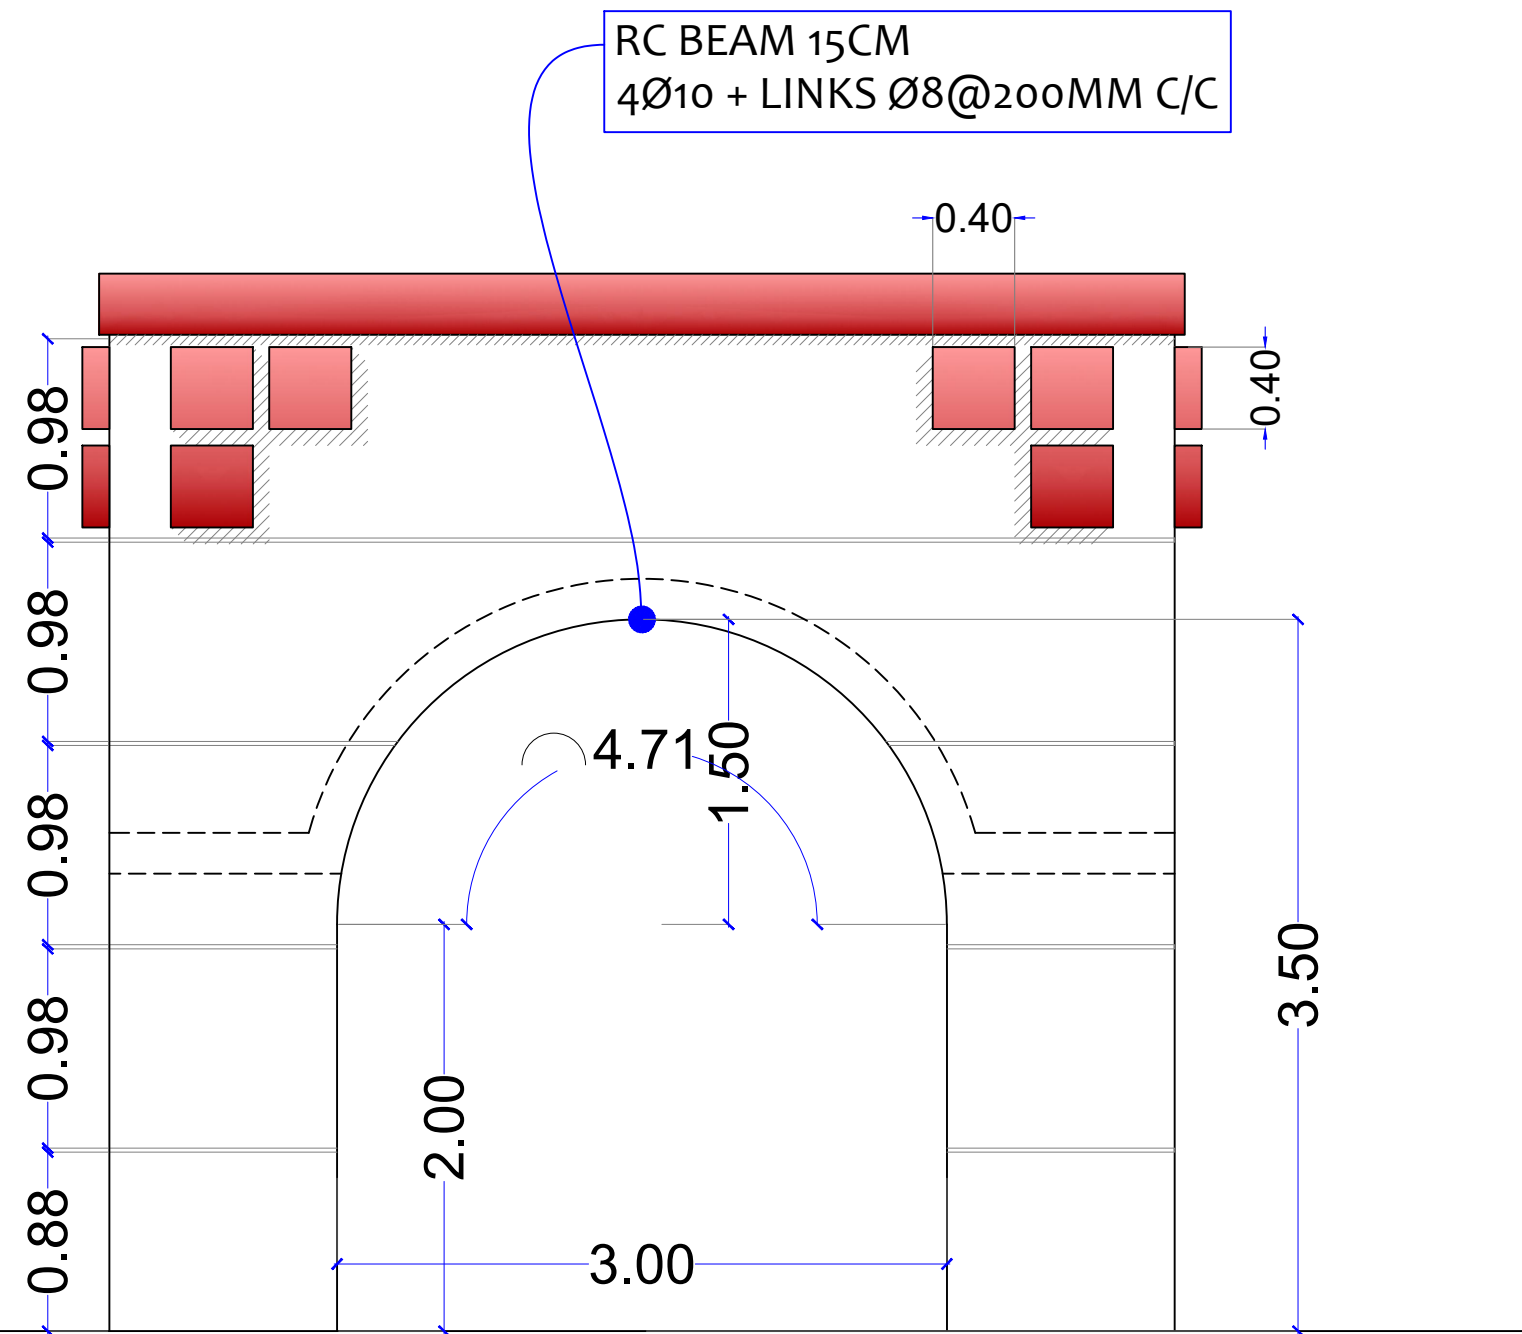


Lead Agency:
UNDP
UNAMID
State Liaison Functions (SLF)
Joint Program

Design by:
Bahauddin Ibrahim
ENGINEERING
Project Management | Design | Supervision
+249 9 123 3 1958
bahauddin.engineering@gmail.com


SECTION

2019

A5

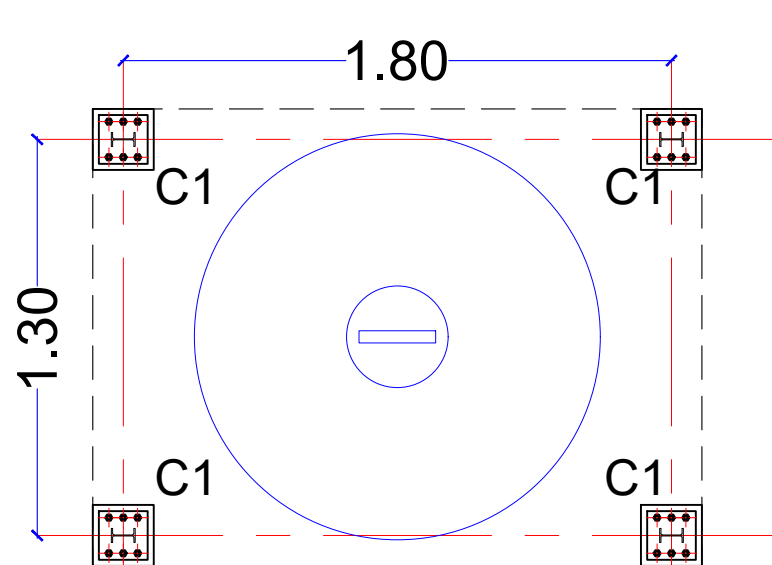

FOUNDATIONS

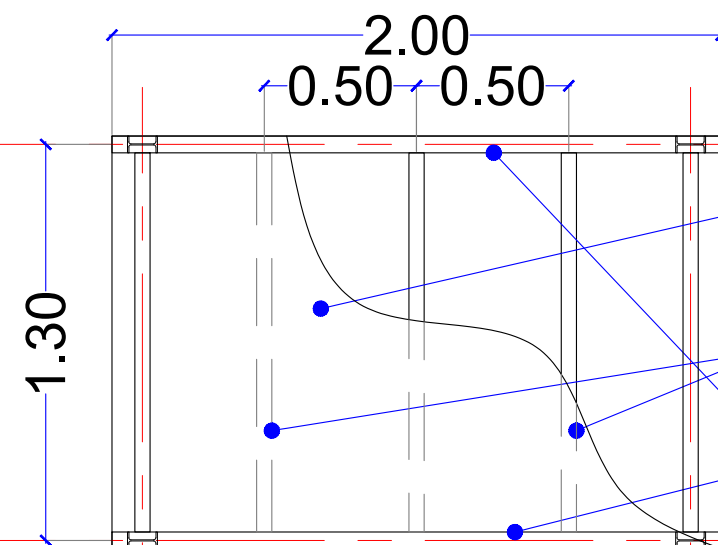

TOP PLAN

CHECKERED STEEL SHEET 5MM.
AREA = 24.4 SQ.M.

L 50X5

L 50X5

L 50X5

IPE-A80
5Kg/m


16X16X10MM.
ST.FLANGE
WELDED TO I-SECTION

NATURAL SOIL

NATURAL SOIL


YØ16@200MM C/C BOTHWAY

FILLED S.MATERIAL

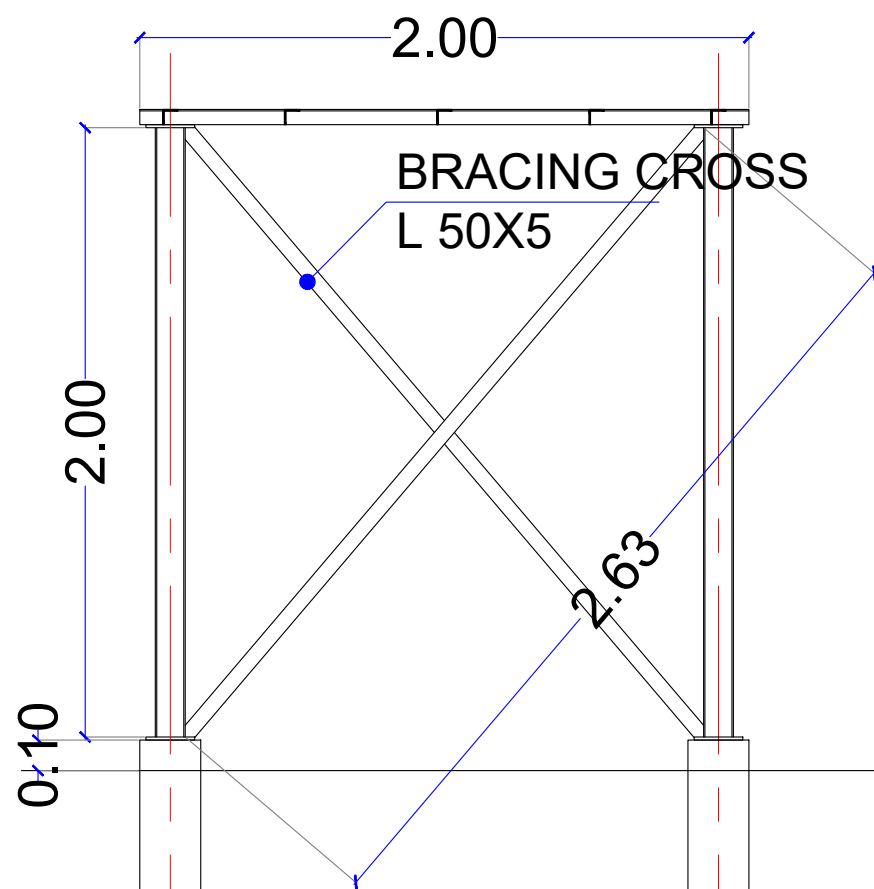

ELEVATION


Water Tank Holder

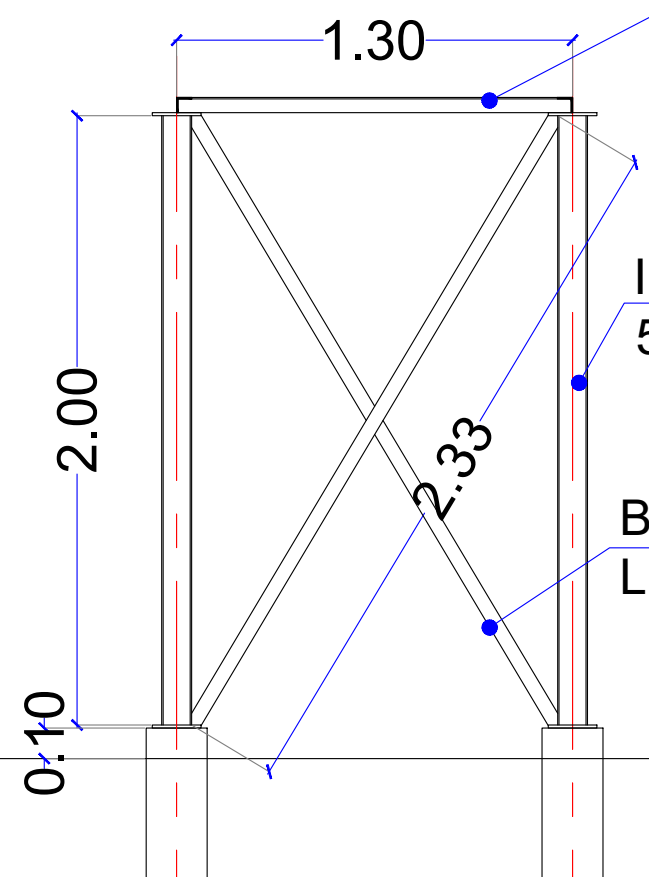


SIDE ELEVATION

6 ANCHOR BOLTS & NUTS

RC. COLUMN : C1

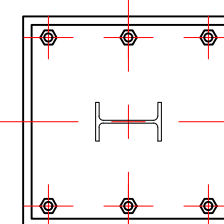

IPE-A80
5Kg/m

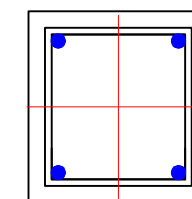

SIZE : 0.20 X 0.20 M

STEEL : Y 4 Ø16 MM.

LINK : 1 X 8MM @ 200MM.



Lead Agency:
UNDP
UNAMID
State Liaison Functions (SLF)

Design by:
Bahauddin Ibrahim
ENGINEERING
Project Management | Design | Supervision
+249 9 123 3 1958
bahauddin.engineering@gmail.com

DETAILS

2019

WT

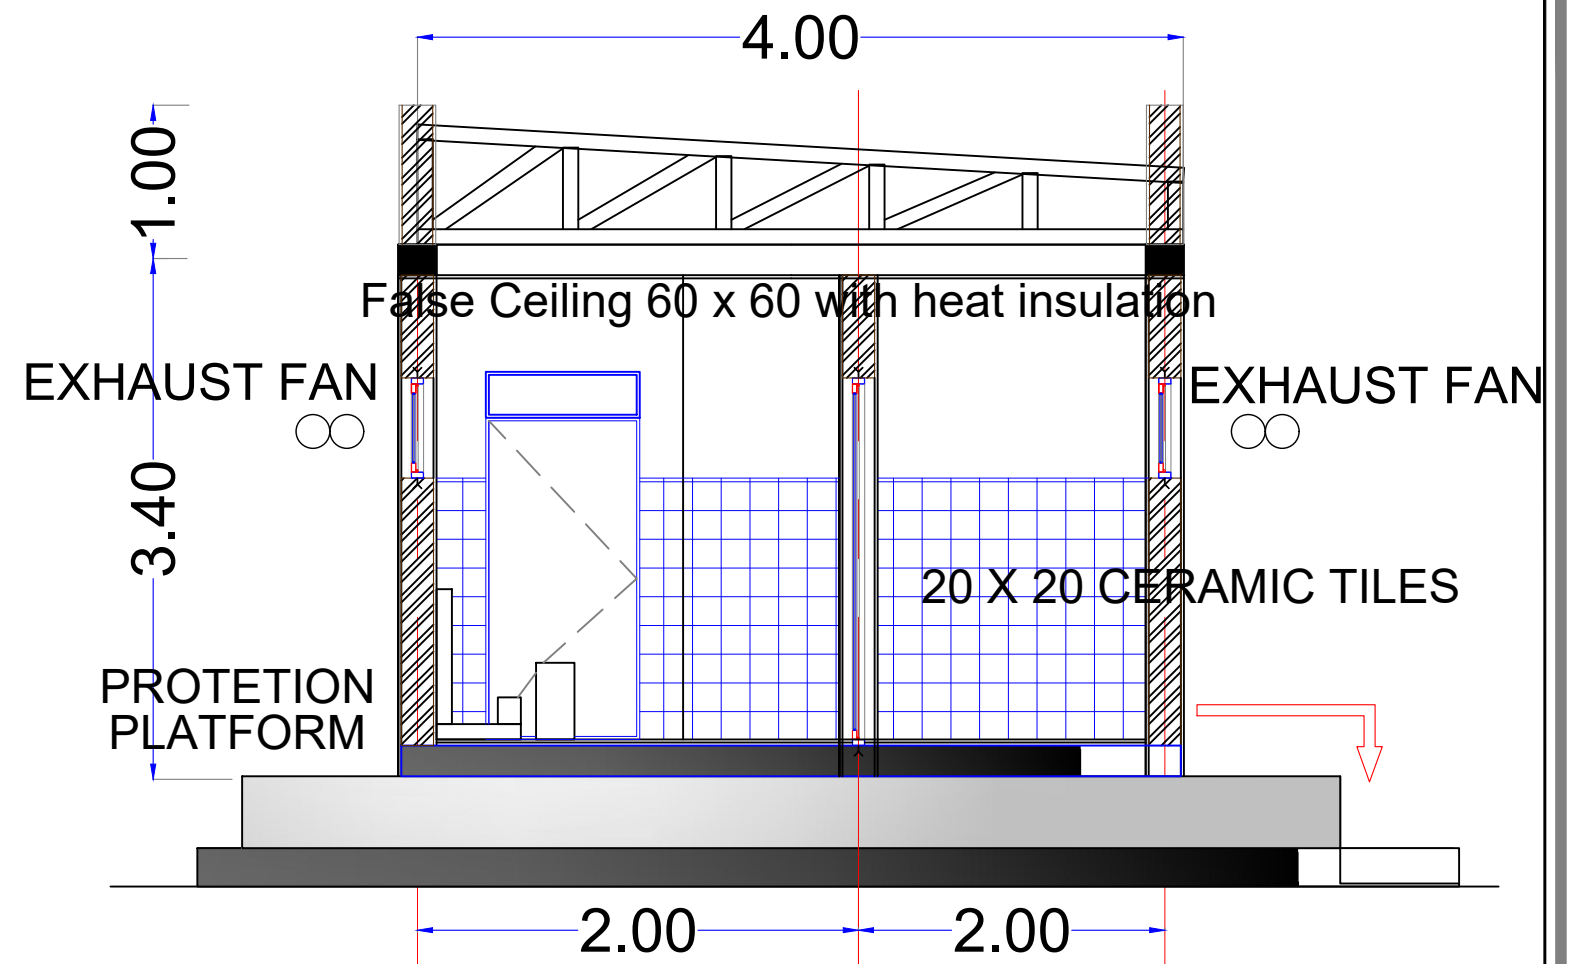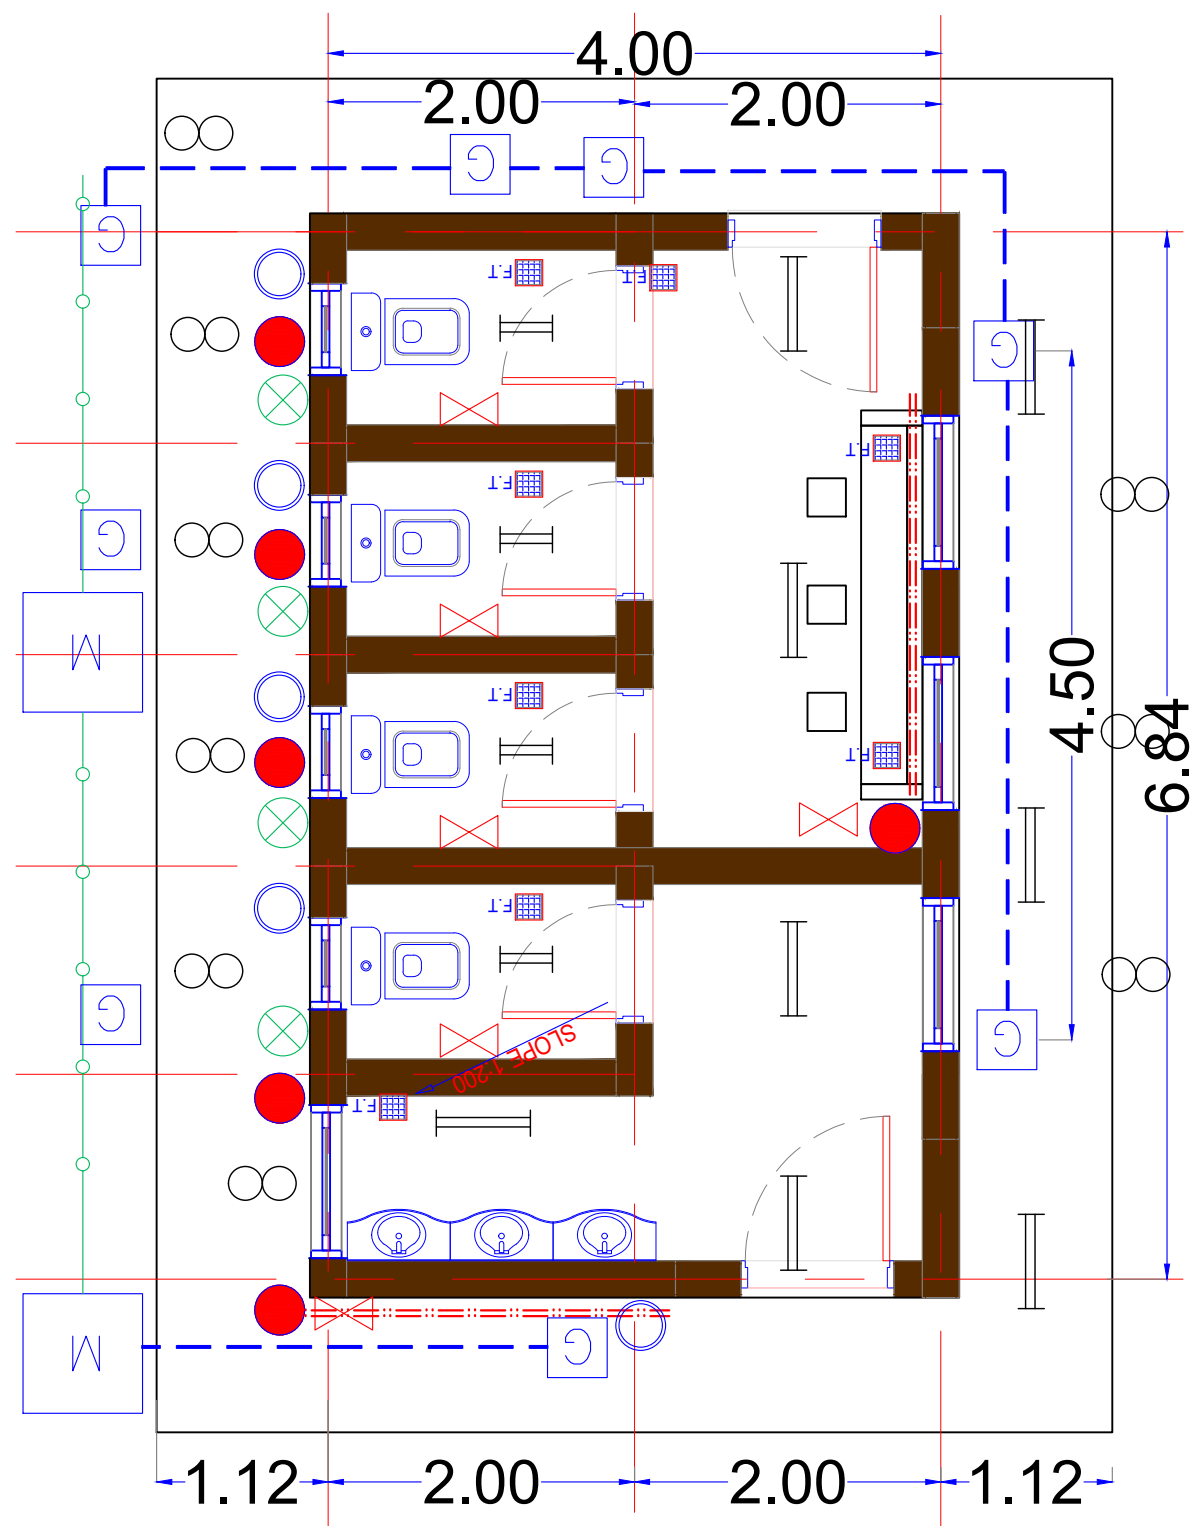

DRAINAGE'S SYMBOL DESCRIPTION

SYMBOL	DESCRIPTION
●	Ø 1" G.S PIPE FOR FRESH WATER
⊗	Ø 4" UPVC SOIL WATER PIPE
○	Ø 2" UPVC WAIST WATER PIPE
⋈	COLD WATER VALVE
F.T.	FLOOR TRAP
—○—	Ø 4" UPVC SOIL WATER PIPE
==	Ø 3/4" G.S PIPE FOR FRESH WATER
- - -	Ø 2" UPVC WAIST WATER PIPE

ELECTRICAL SYMBOL KEY:

S	Description
∞	EXHAUST FAN
⌌	2 ft SINGLE FLOURECENT LAMP
⌌	4 ft SINGLE FLOURECENT LAMP


Lead Agency:
UNDP
UNAMID
 State Liaison Functions (SLF)

Design by:
Bahauddin Ibrahim
ENGINEERING
 Project Management | Design | Supervision
 +249 9 123 3 1958
 bahauddin.engineering@gmail.com


Detailed Section

December
2018

D3


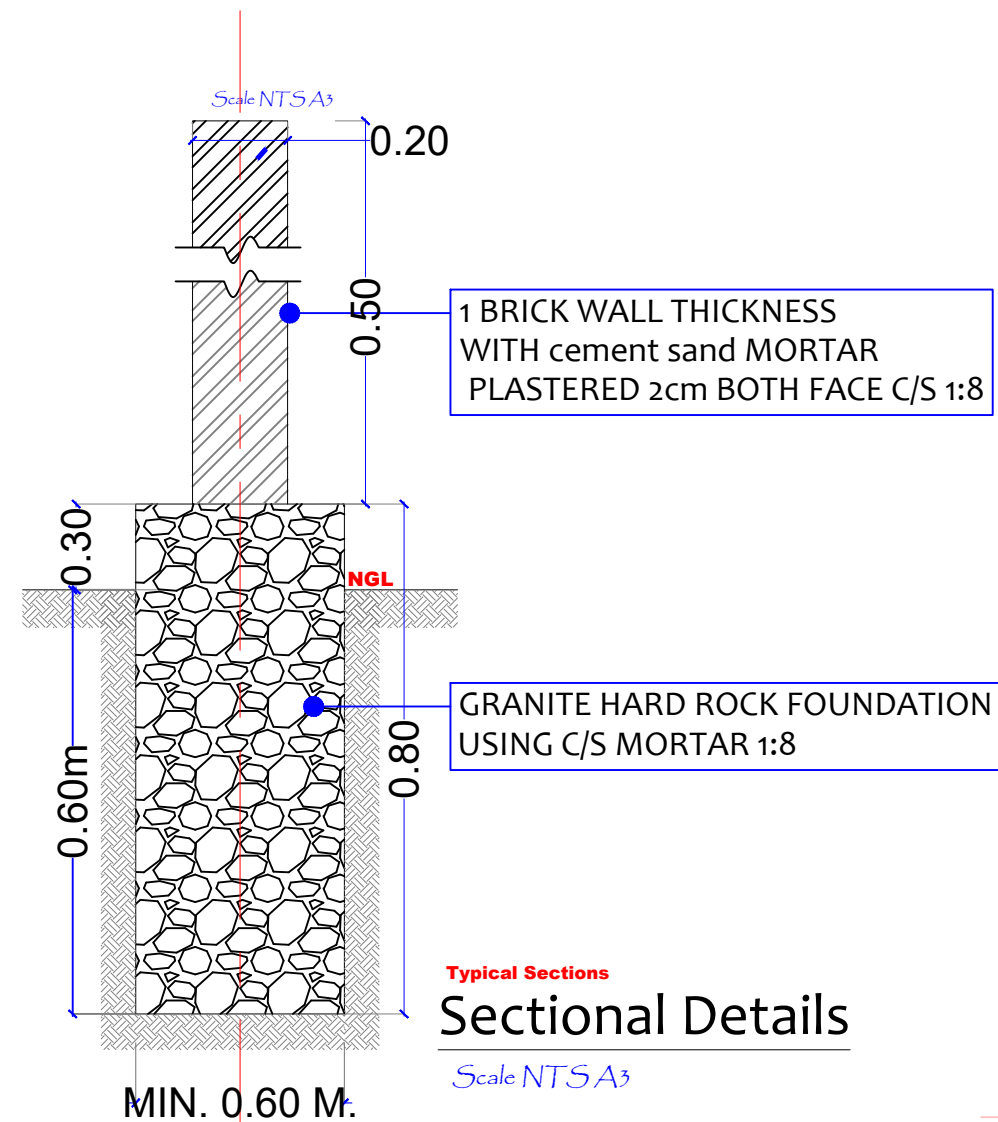


Typical Sections
Sectional Details
Scale NTSA3

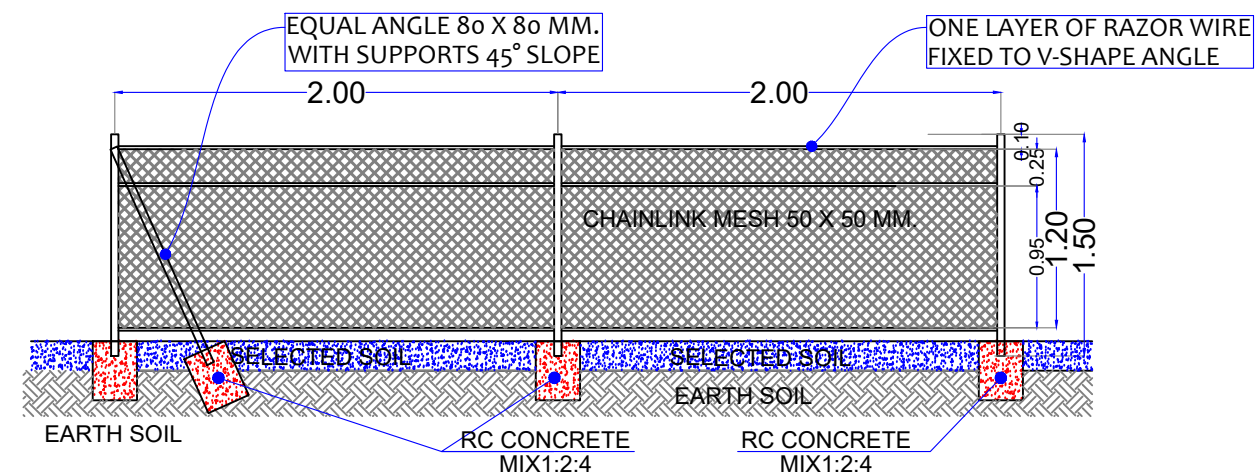

FENCE TYPICAL DETAILS

1 BRICK WALL THICKNESS
WITH cement sand MORTAR
PLASTERED 2cm BOTH FACE C/S 1:8

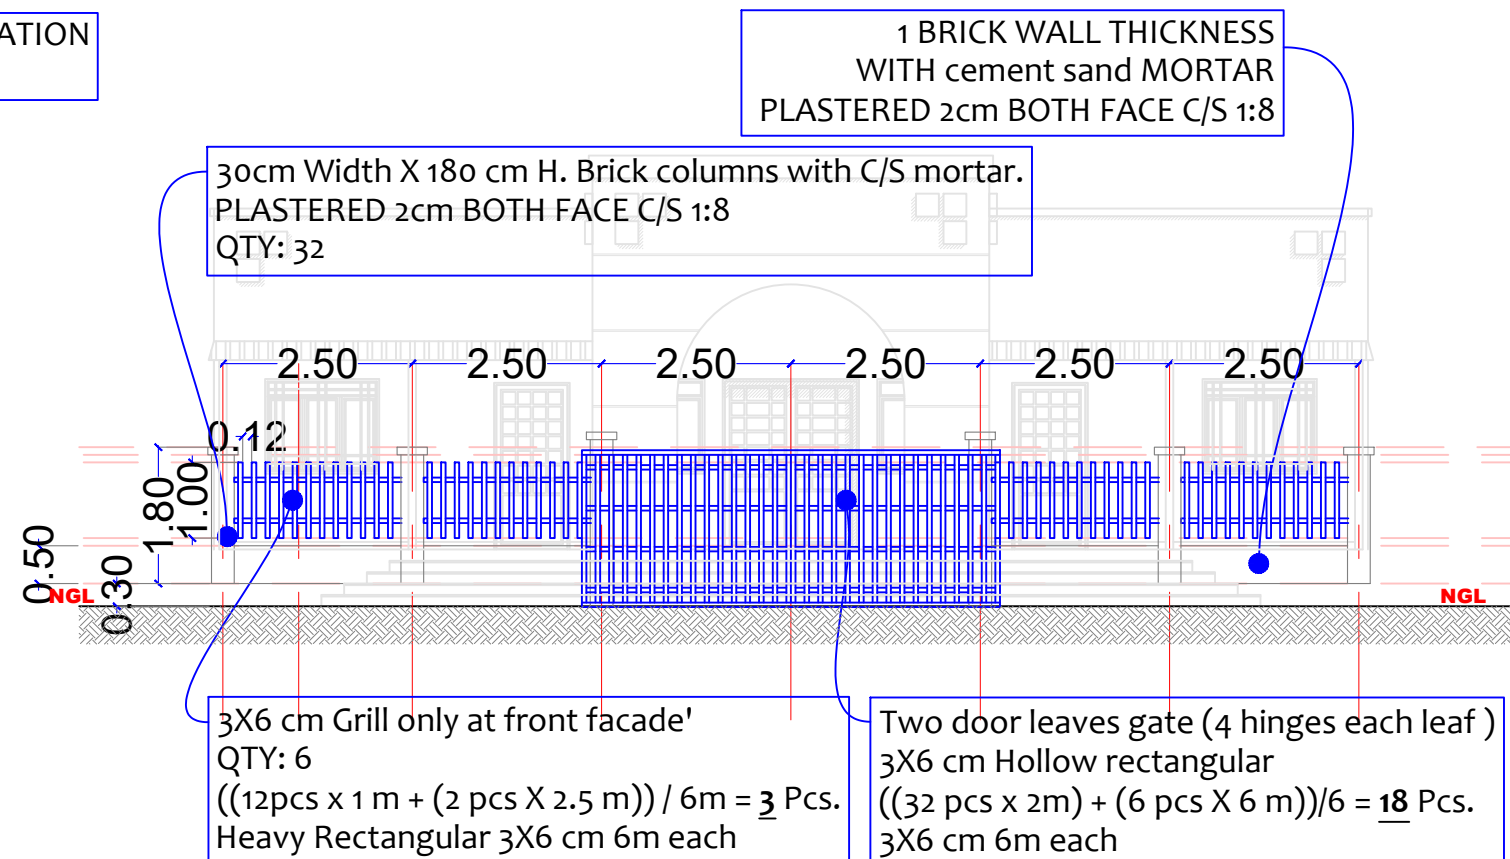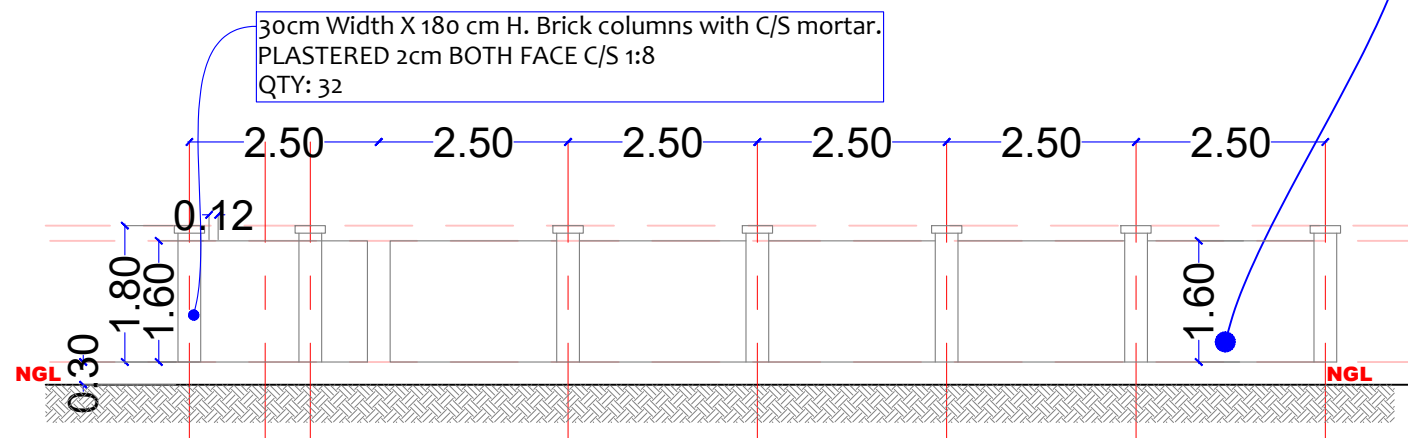

Lead Agency:
UNDP
UNAMID
State Liaison Functions (SLF)

Design by:
Bahauddin Ibrahim
ENGINEERING
Project Management | Design | Supervision
+249 9 123 3 1958
bahauddin.engineering@gmail.com


STANDARD MODEL
Boundary Wall

2018

F1

IN

OUT

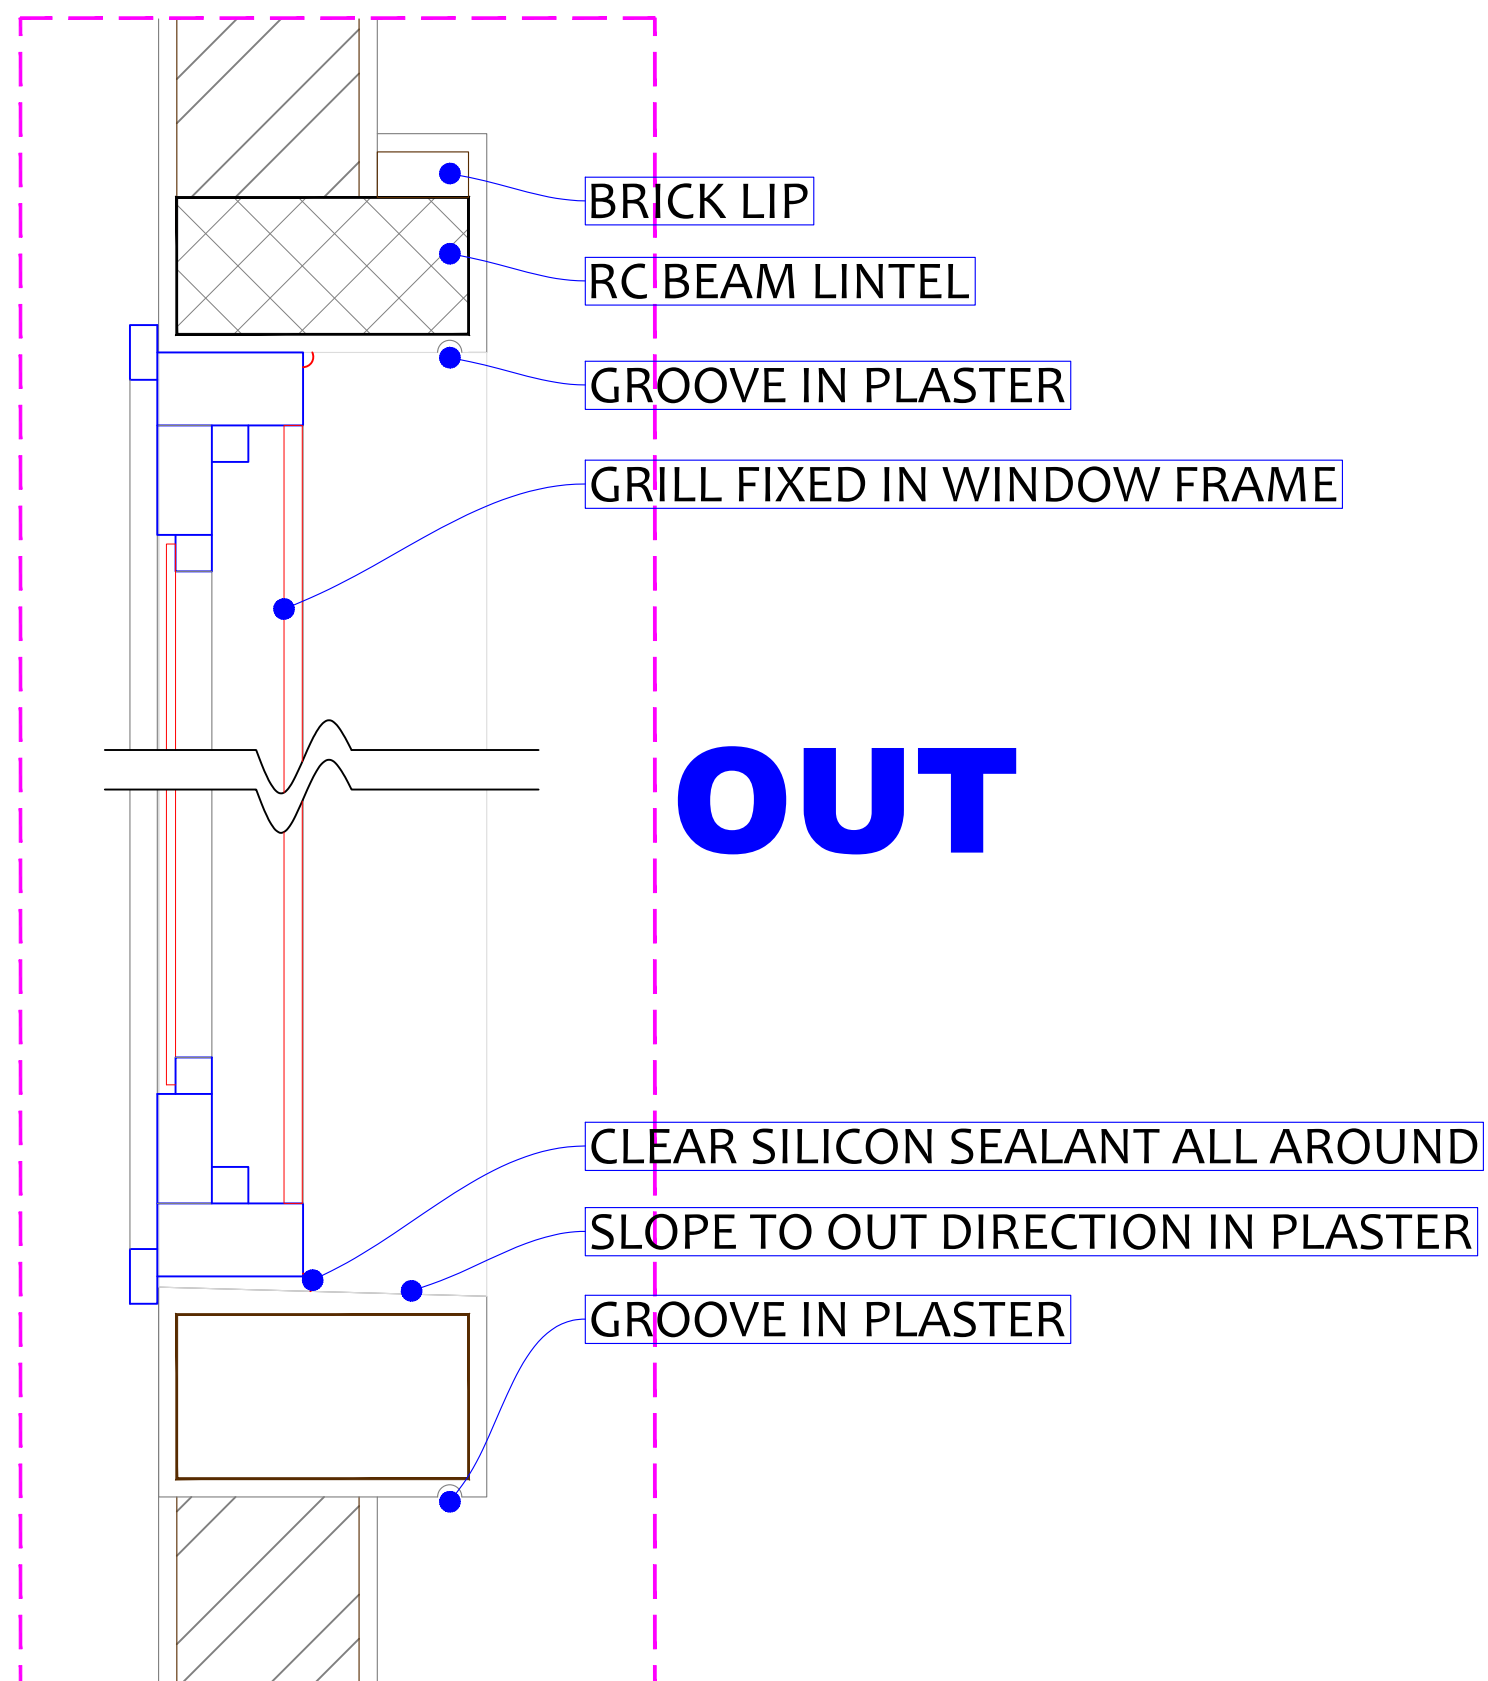

Lead Agency:
UNDP
UNAMID
State Liaison Functions (SLF)

Design by:
Bahauddin Ibrahim
ENGINEERING
Project Management | Design | Supervision
+249 9 123 3 1958
bahauddin.engineering@gmail.com

Detailed Section

December
2018

D1

D1 Painted Steel

Width 800xH.2150mm

Hinged STEEL DOOR


LEXAN @ Door Leaf

Frame (4X8 Tube)
Door Leaf (3X6 Tube)

3 Hinges Each Leaf

1 Handle & 2 Latch

FRAME 4X 8 AND DOOR LEAF 3X6
 $\frac{3}{4}$ " Rectangular H&V LEXAN @ DOOR LEAF
FINISHED OIL PAINTS 3 COATS ON
3 COATS OF ANTI-CORROSION PAINT
3 HEAVY DUTY HINGES

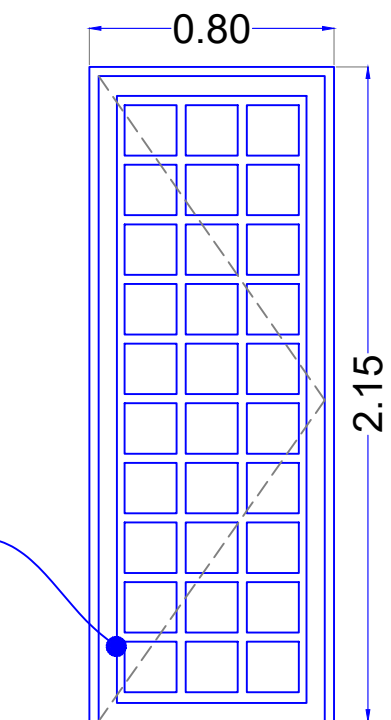

D2 Painted Steel

Width 1000xH.2150mm

Hinged STEEL DOOR


LEXAN @ Door Leaf

Frame (4X8 Tube)
Door Leaf (3X6 Tube)

3 Hinges Each Leaf

1 Handle & 2 Latch

FRAME 4X 8 AND DOOR LEAF 3X6
 $\frac{3}{4}$ " Rectangular H&V LEXAN @ DOOR LEAF
FINISHED OIL PAINTS 3 COATS ON
3 COATS OF ANTI-CORROSION PAINT
3 HEAVY DUTY HINGES

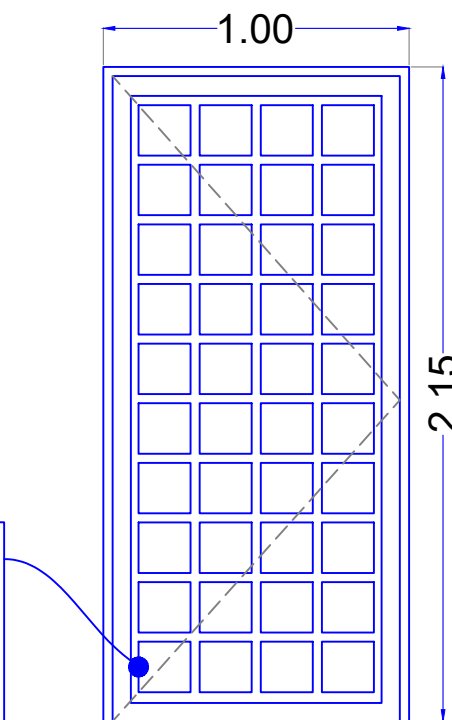

Lead Agency:
UNDP
UNAMID
State Liaison Functions (SLF)

Design by:
Bahuddin Ibrahim
ENGINEERING
Project Management | Design | Supervision
+249 9 1233 1958
bahuddin.engineering@gmail.com


Detailed Section

December
2018


D2

W2 Painted Steel QTY = 5 Width 1500xH.1250mm

Hinged Window
Flyscreen Mesh
6mm Glaze
Frame (4X8 Tube)
Window Leaf (3X6 Tube)
Grill (3/4" X 3/4" Tube)
3 Handle & 6 Latch

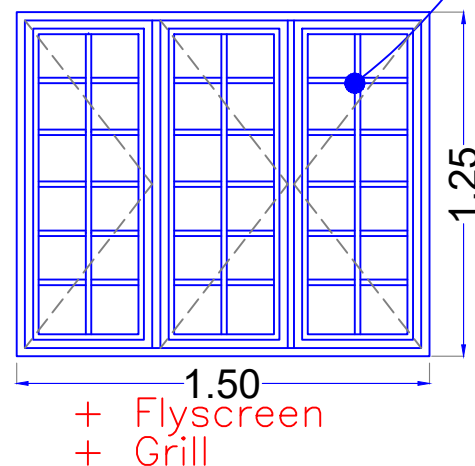


FRAME 4X 8 AND DOOR LEAF 3X6
 $\frac{3}{4}$ " Rectangular H&V LEXAN @ DOOR LEAF
FINISHED OIL PAINTS 3 COATS ON
3 COATS OF ANTI-CORROSION PAINT
3 HEAVY DUTY HINGES

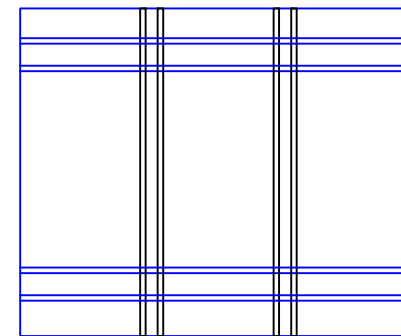


W3 Painted Steel QTY = 4 Width 1500xH.1250mm

Hinged Window
Flyscreen Mesh
4MM LEXAN
Frame (4X8 Tube)
Window Leaf (3X6 Tube)
Grill (3/4 X 3/4" Tube)
2 Handle & 4 Latch

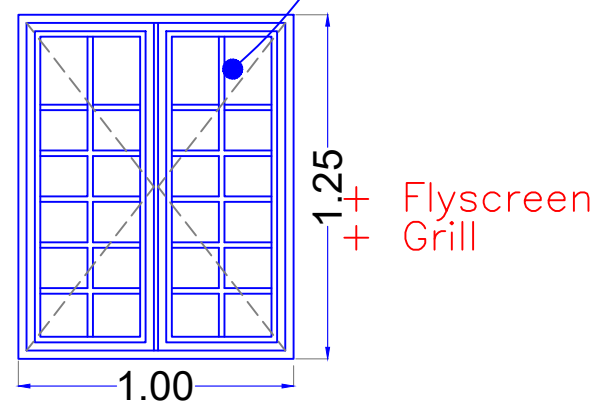

FRAME 4X 8 AND DOOR LEAF 3X6
 $\frac{3}{4}$ " Rectangular H&V LEXAN @ DOOR LEAF
FINISHED OIL PAINTS 3 COATS ON
3 COATS OF ANTI-CORROSION PAINT
3 HEAVY DUTY HINGES

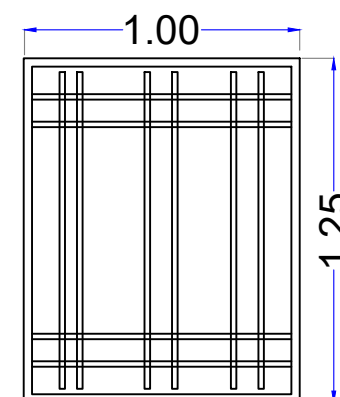


Lead Agency:
UNDP
UNAMID
State Liaison Functions (SLF)

Design by:
Bahauddin Ibrahim
ENGINEERING
Project Management | Design | Supervision
+249 9 123 3 1958
bahauddin.engineering@gmail.com

Detailed Section

December
2018

D3

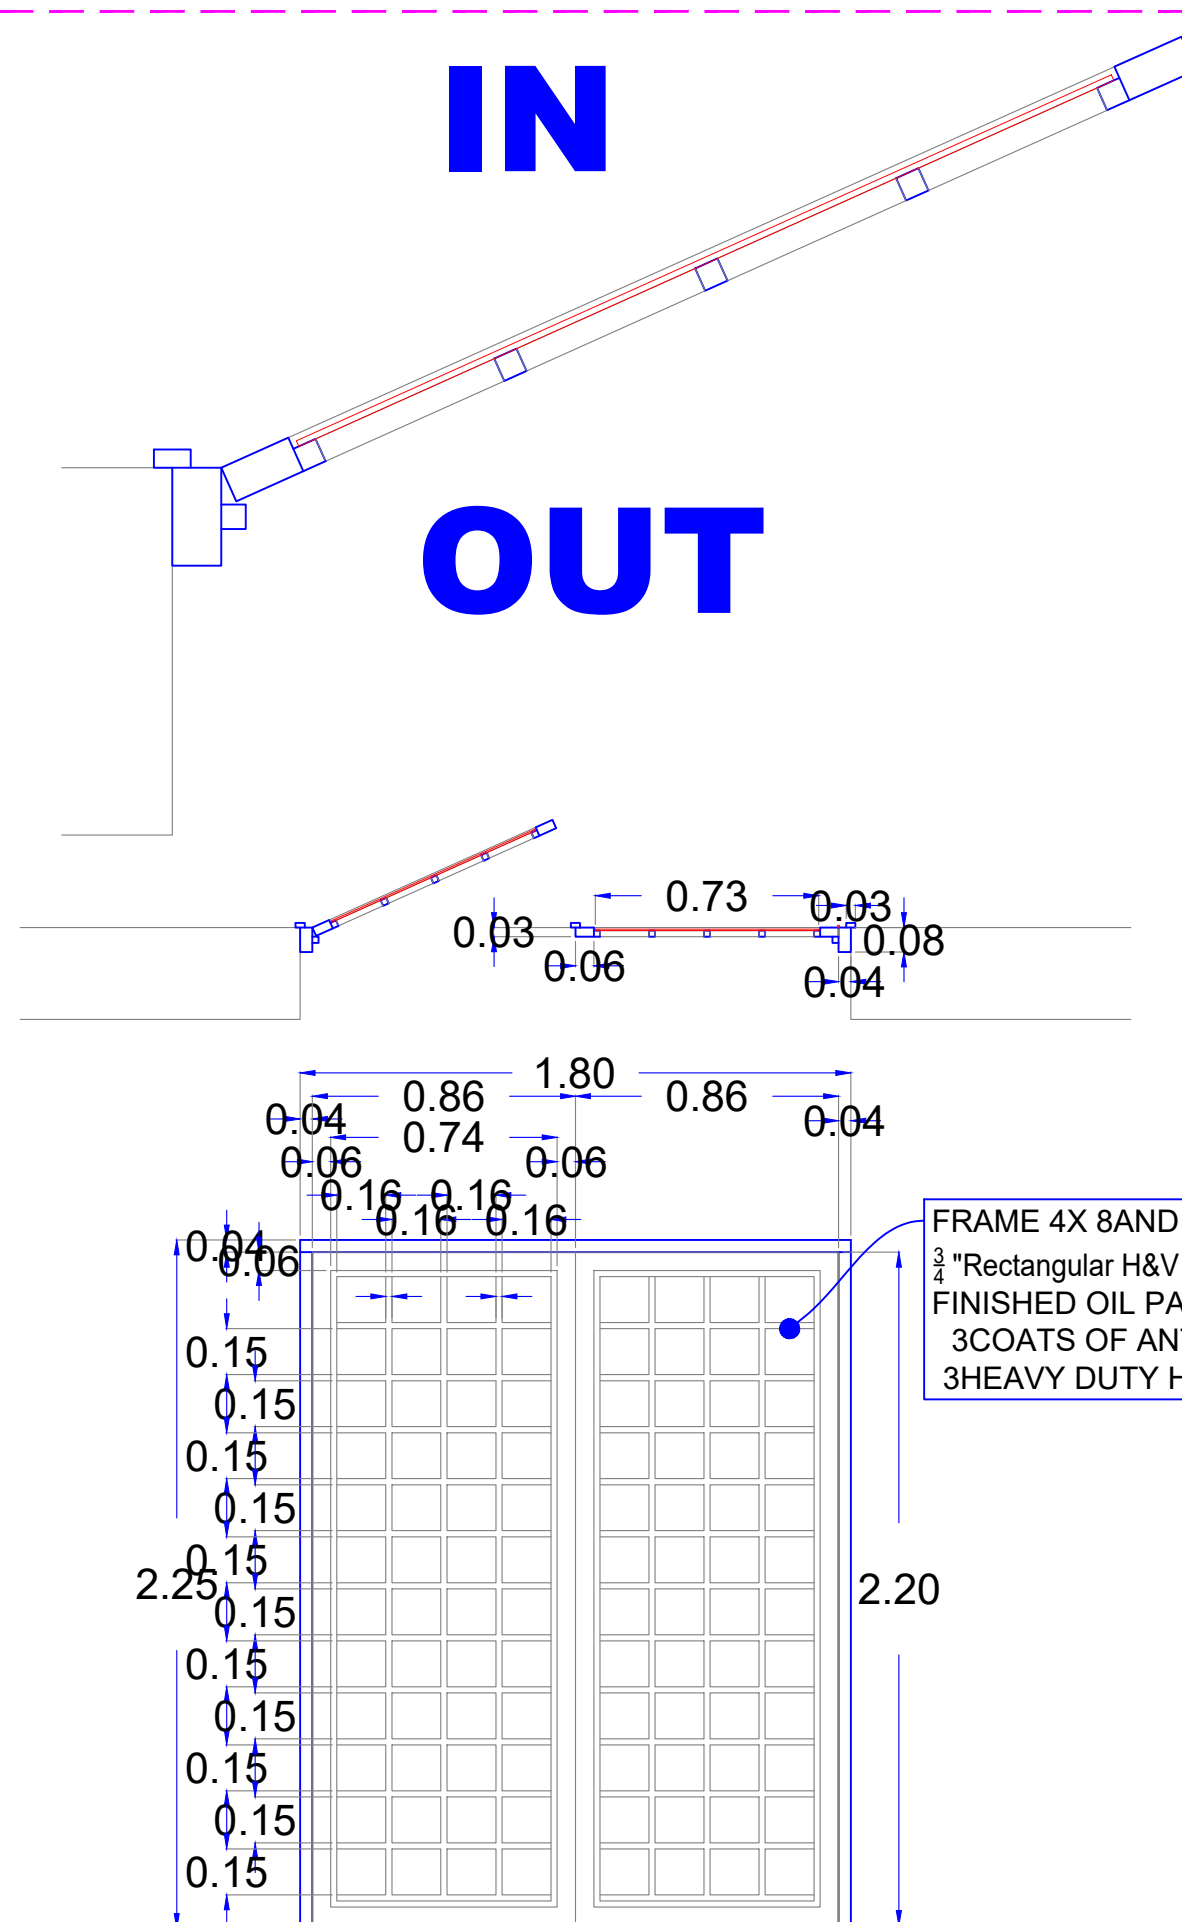

D4 Painted Steel QTY = 1
Width 1800xH.2150mm

Hinged STEEL DOOR

LEXAN @ Door Leaf

Frame (4X8 Tube)

Door Leaf (3X6 Tube)

3 Hinges Each Leaf

1 Handle & 2 Latch


Lead Agency:
UNDP
UNAMID
State Liaison Functions (SLF)

Design by:
Bahauddin Ibrahim
ENGINEERING
Project Management | Design | Supervision
+249 9 123 3 1958
bahauddin.engineering@gmail.com


Detailed Section

December
2018

D4

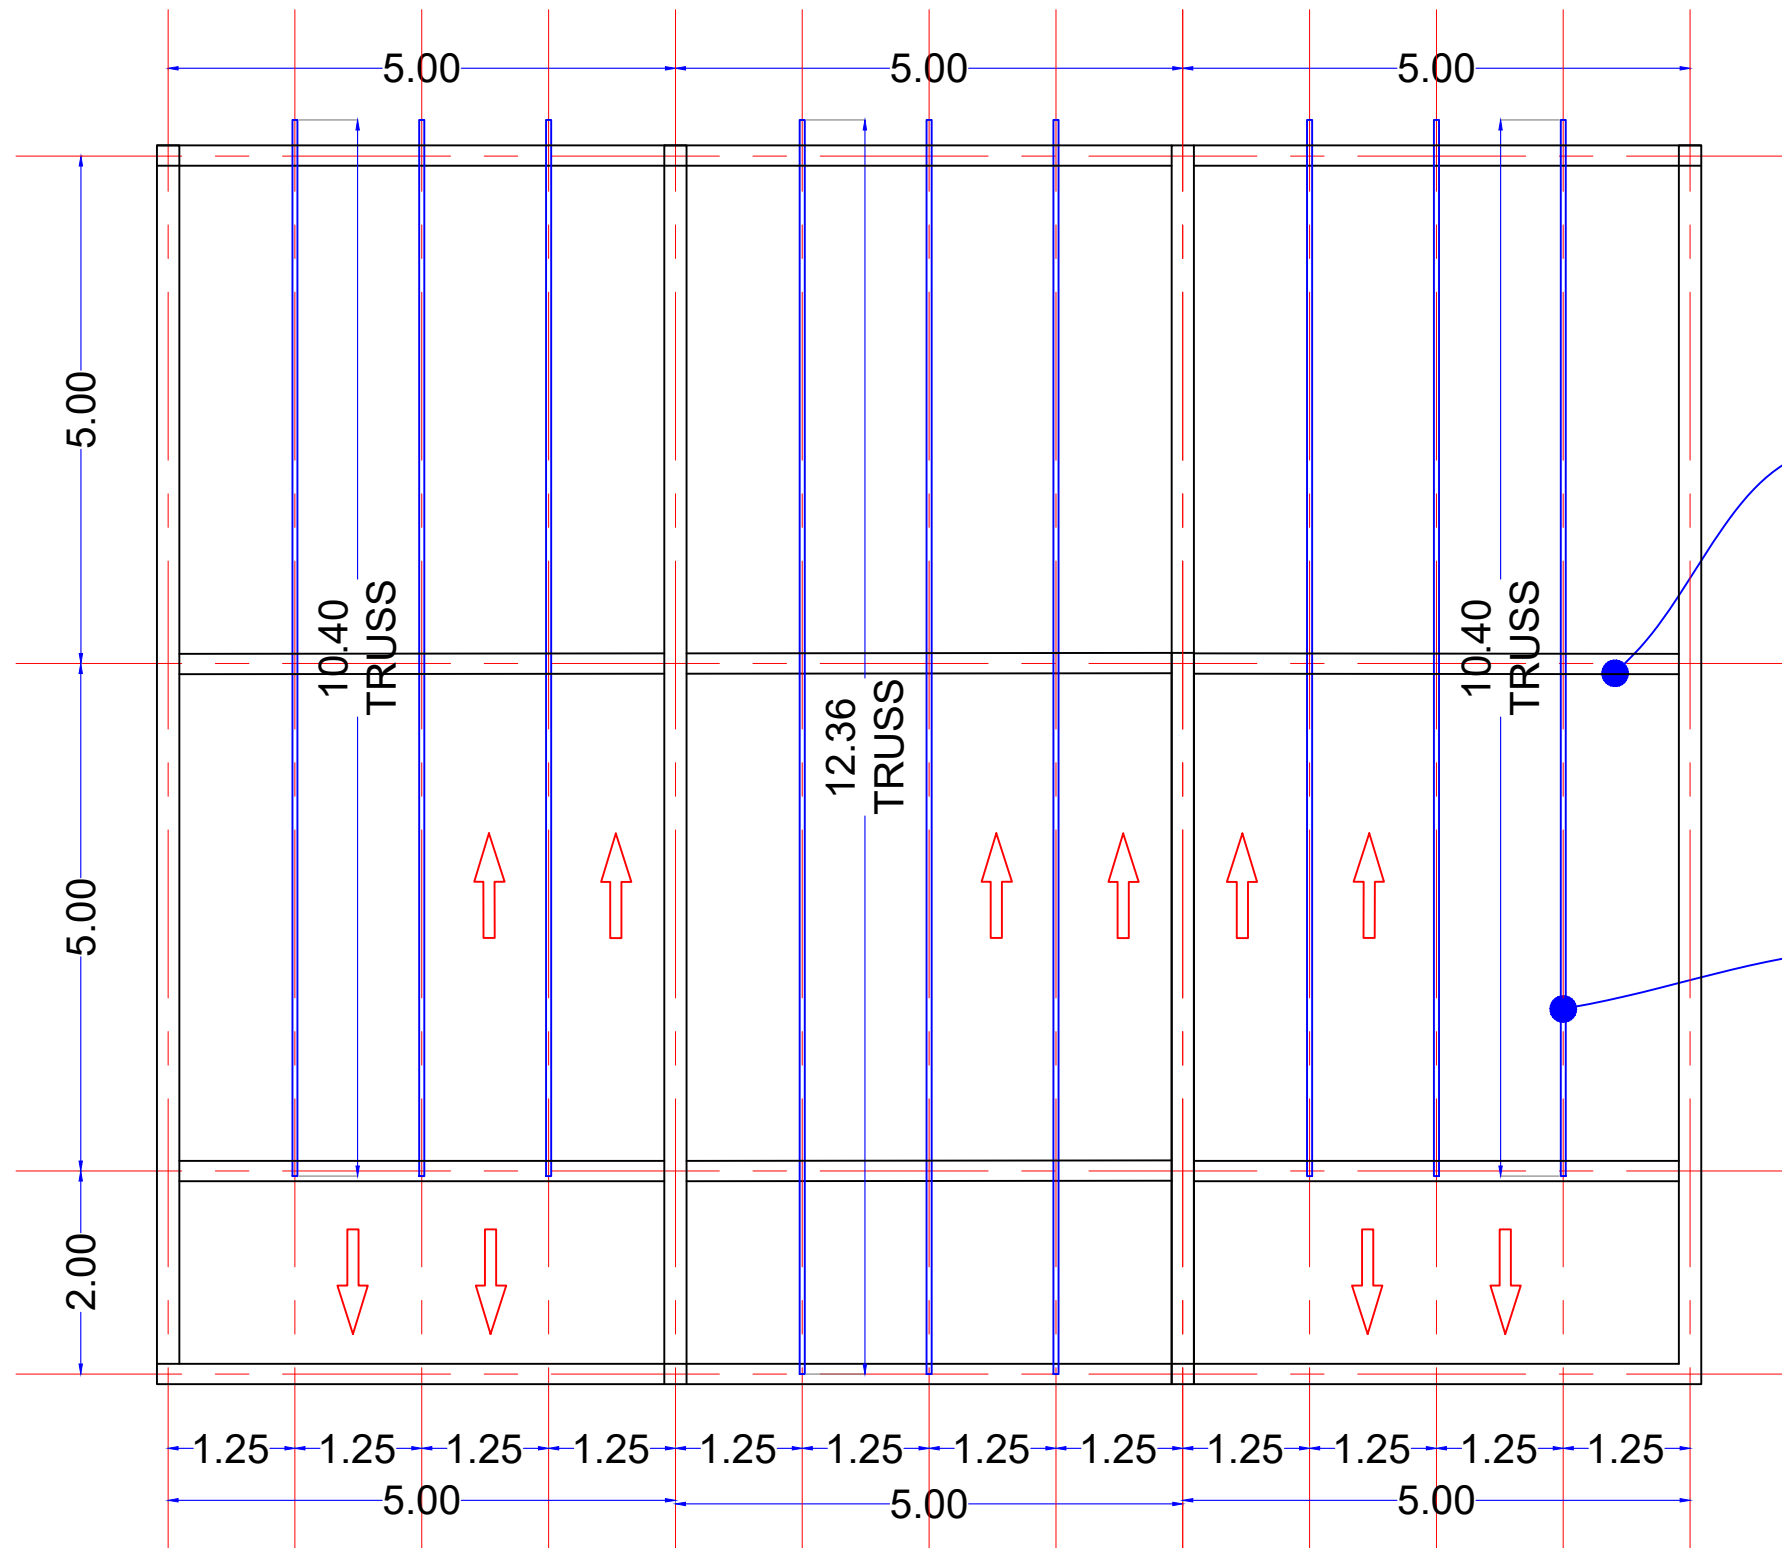

RC ROOF BEAM (G25)
4 DIA 10MM LINKS 8MM @ 200 C/C

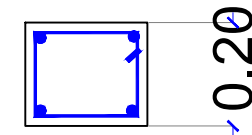

STEEL TRUSSES @ 1.25M C/C
4X 8CM SECTION
3COATS OF ANTI-CORROSION PAINT

ROOF BEAMS & TRUSS LAYOUT


Lead Agency:
UNDP
UNAMID
State Liaison Functions (SLF)
Joint Program

Design by:
Bahauddin Ibrahim
ENGINEERING
Project Management | Design | Supervision
+249 9 123 3 1958
bahauddin.engineering@gmail.com


DETAILS

2019


S1

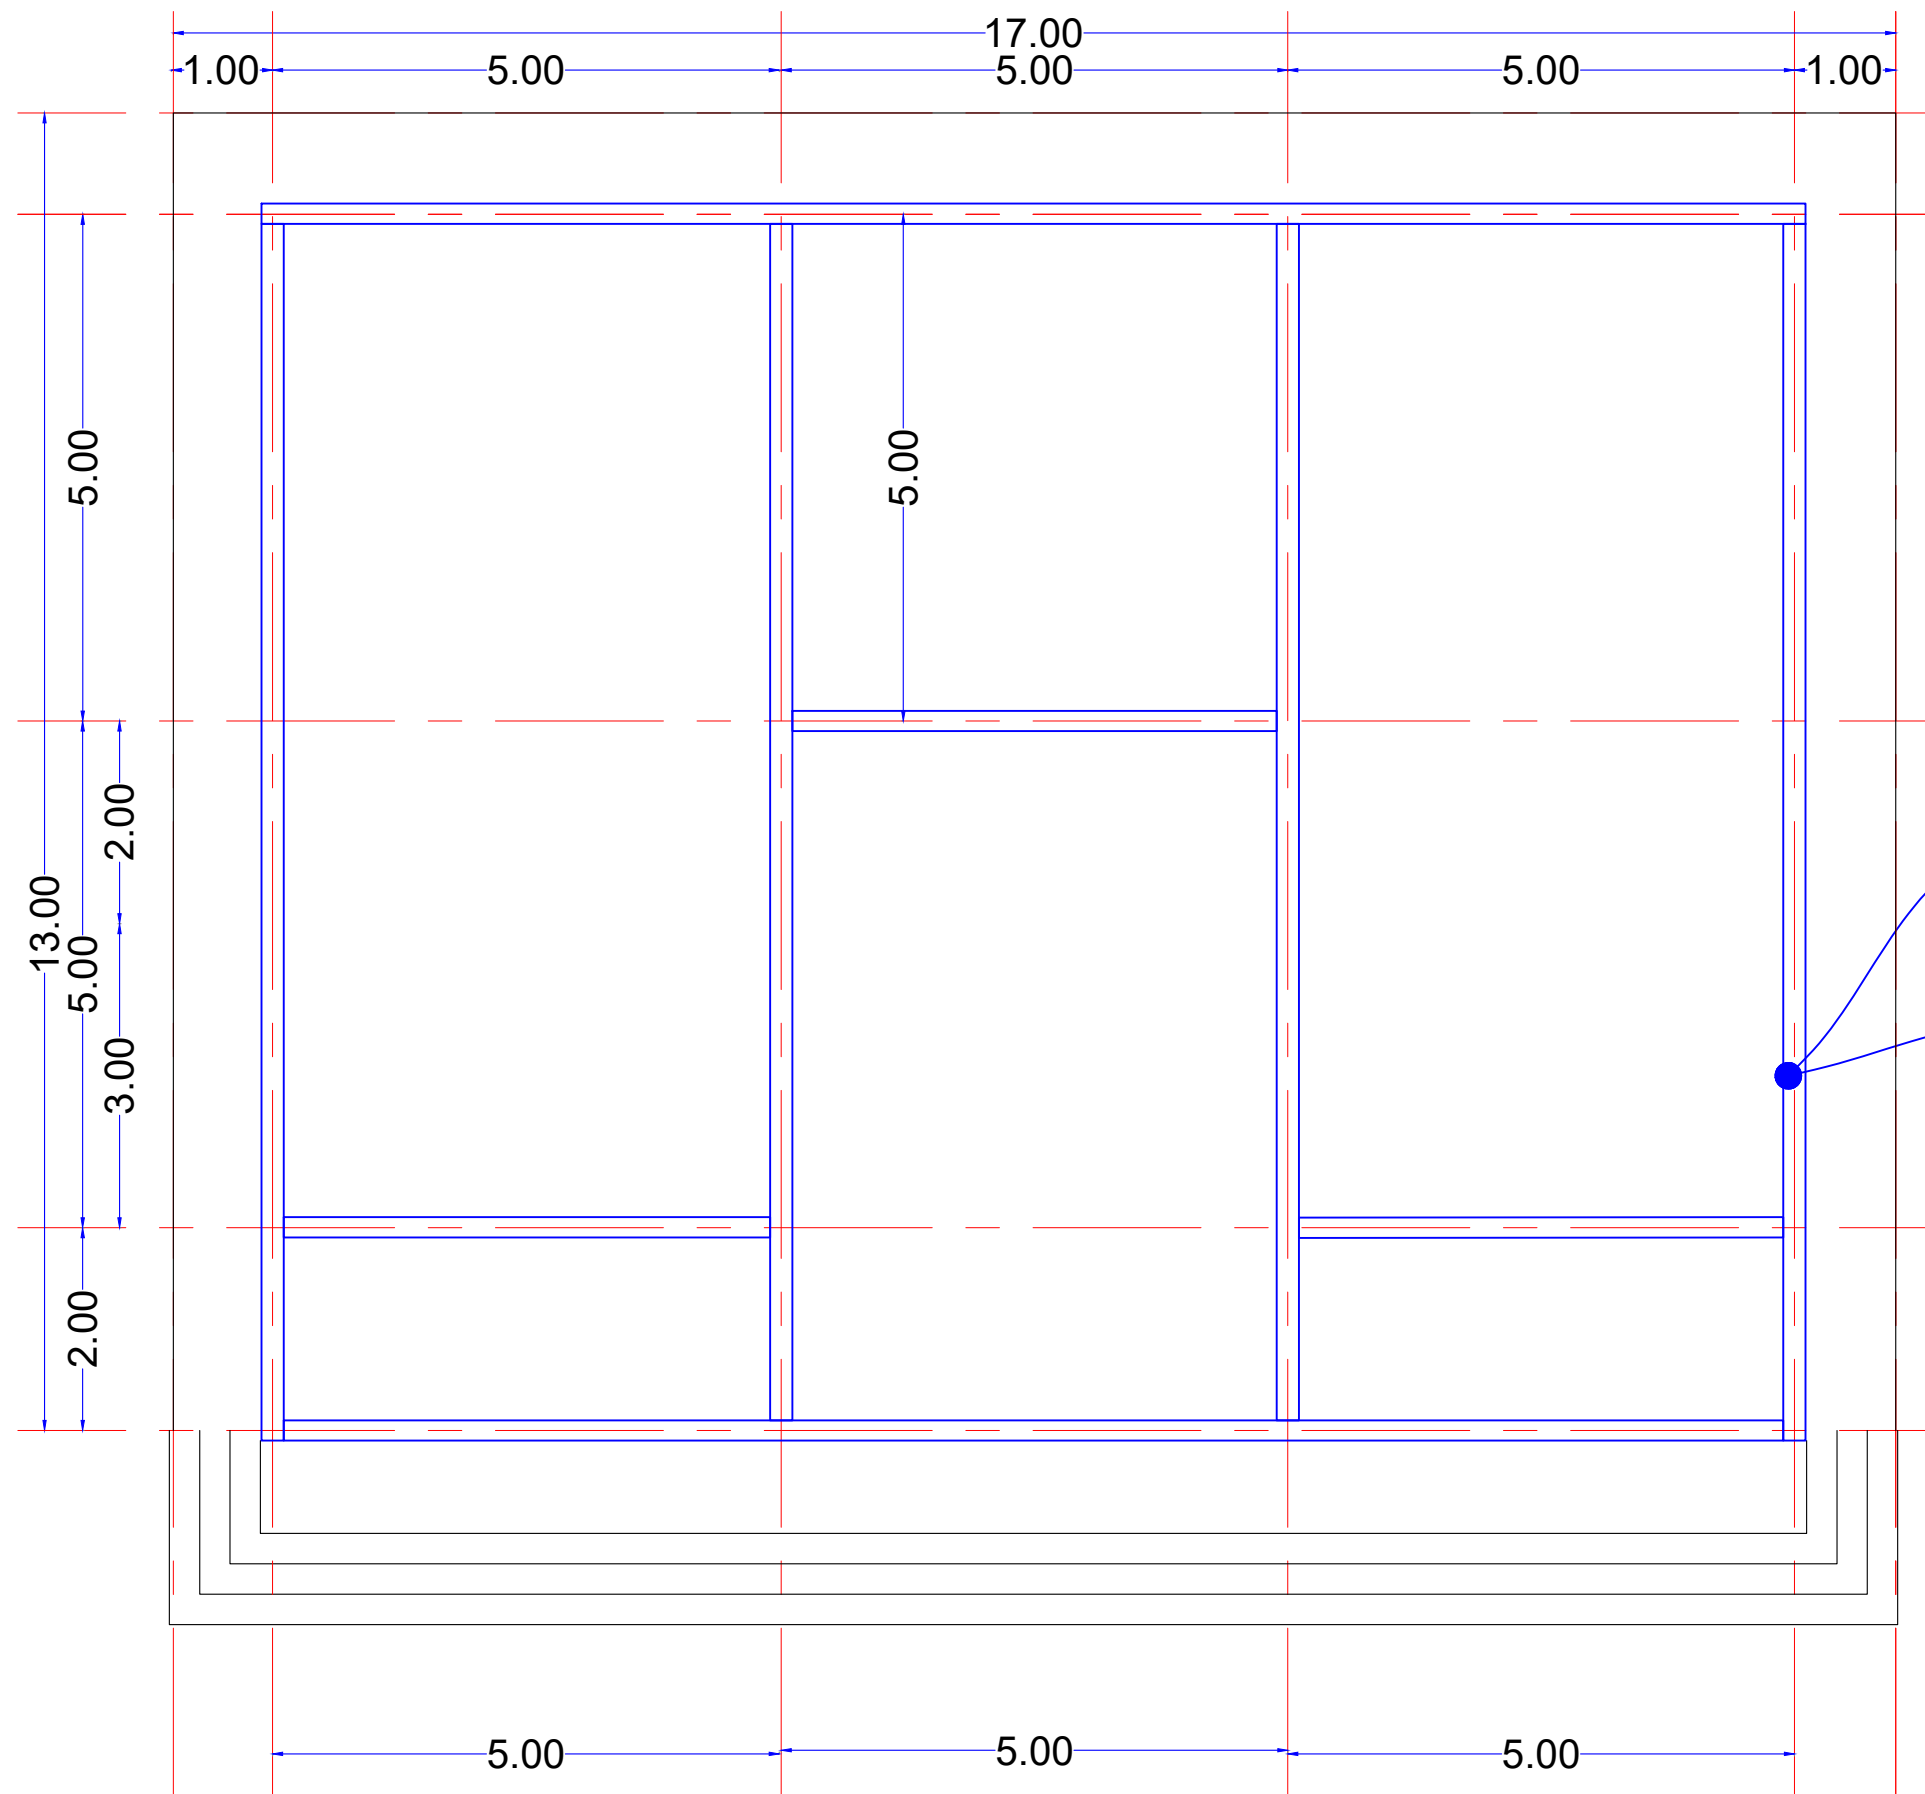

RC ROOF BEAM (G25)
4 DIA 10MM LINKS 8MM @ 200 C/C

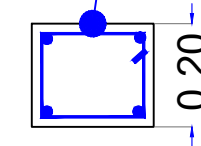

RC GRADE BEAM (G25)
6 DIA 16MM LINKS 8MM @ 200C/C

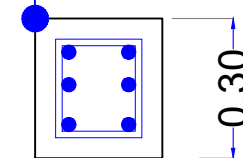

RC ROOF BEAM (G25)
4 DIA 10MM LINKS 8MM @ 200 C/C

RC GRADE BEAM (G25)
6 DIA 16MM LINKS 8MM @ 200C/C

Lead Agency:

UNDP
UNAMID
State Liaison Functions (SLF)
Joint Program

Design by:


Bahauddin Ibrahim
ENGINEERING

Project Management | Design | Supervision
+249 9 123 3 1958
bahauddin.engineering@gmail.com


DETAILS

2019

S2

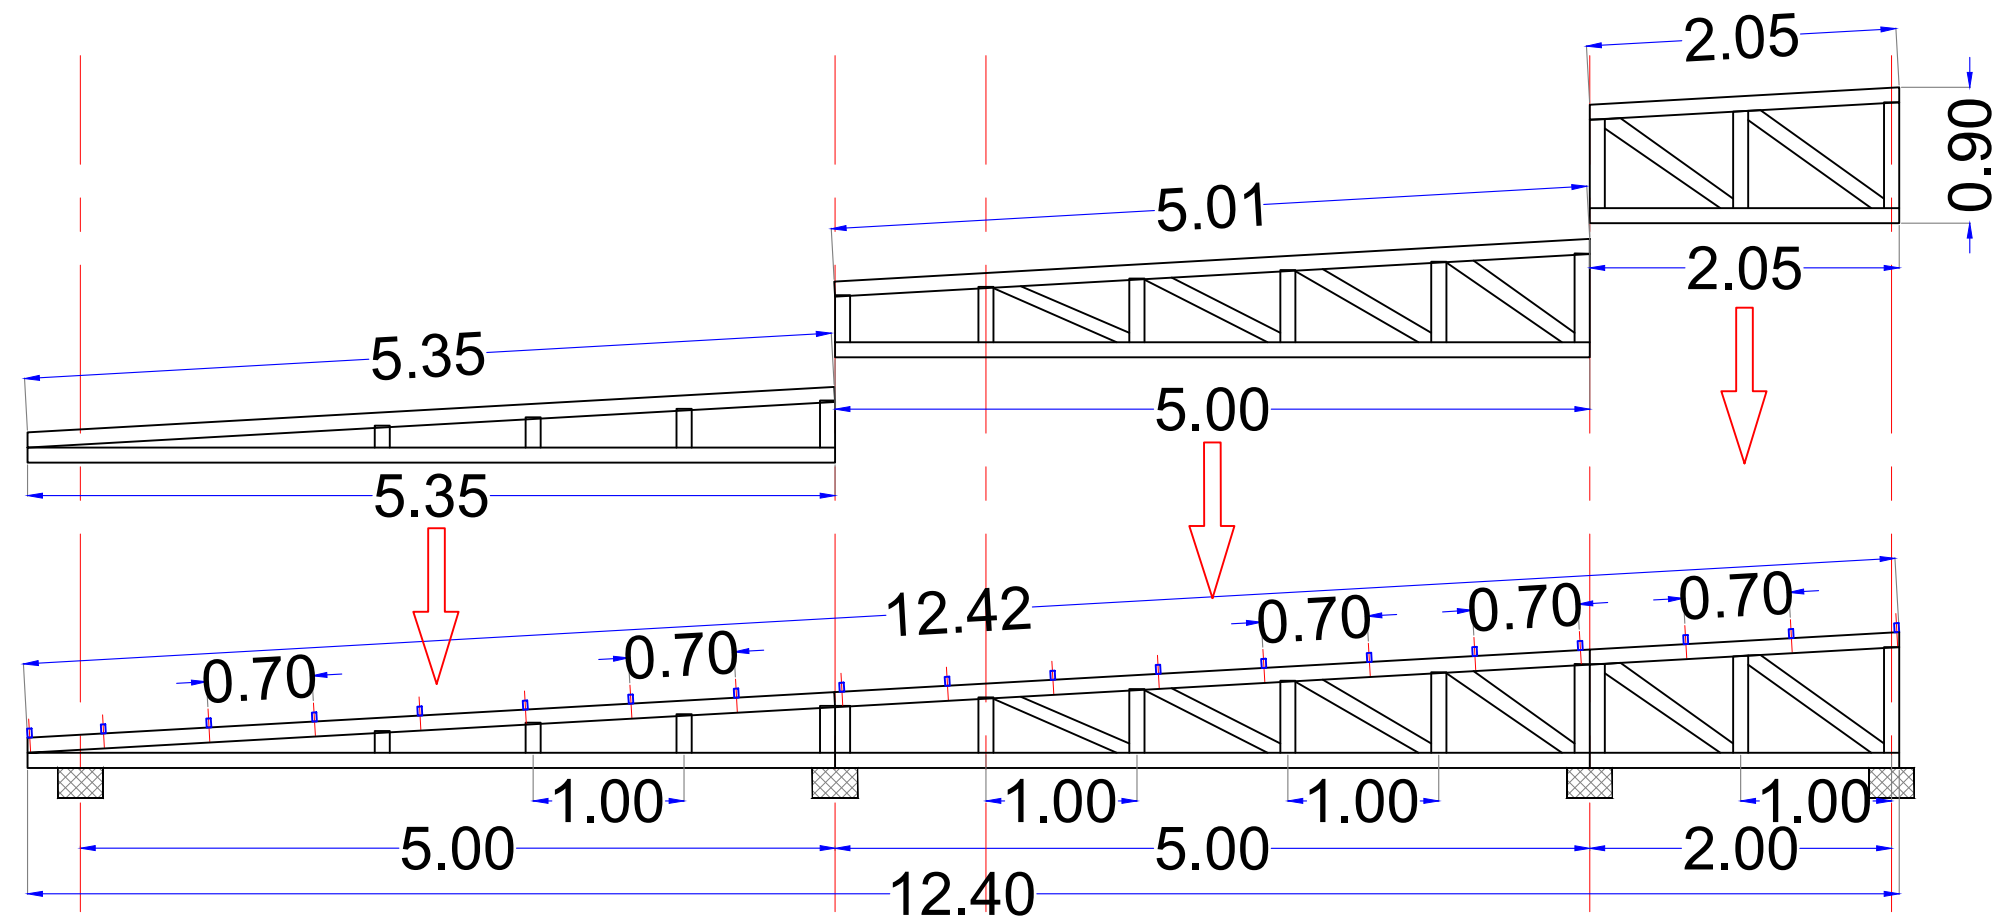

STEEL TRUSS DETAILS

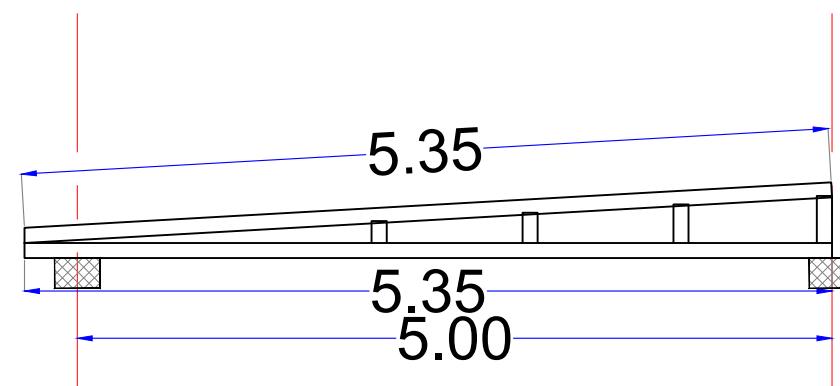

Lead Agency:
UNDP
UNAMID
State Liaison Functions (SLF)

Design by:
Bahauddin Ibrahim
ENGINEERING
Project Management | Design | Supervision
+249 9 123 3 1958
bahauddin.engineering@gmail.com

Details

December
2018

S3