



THE KINGDOM OF SAUDI ARABIA THROUGH
THE SAUDI FUND FOR DEVELOPMENT (SFD)



PROJECT Name:

Reconstruction and repair works of more than 150 effected houses for non-refugees and Rehabilitation and Furniture for field playgrounds and a culture center.


Lot#10-B: Construction of The External Toilet Units in Beit hanoun & Al-Yarmouk playgrounds.

DONATED BY :

THE KINGDOM OF SAUDI ARABIA THROUGH
THE SAUDI FUND FOR DEVELOPMENT (SFD)

EMPLOYER:

UNITED NATIONS RELIEF AND WORKS AGENCY
(UNRWA) THROUGH UNITED NATIONS
DEVELOPMENT PROGRAMME (UNDP/PAPP)

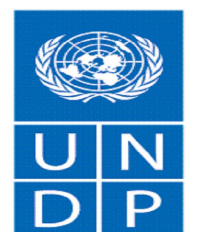

*Empowered lives.
Resilient nations.*




FUNDED BY :
THE KINGDOM OF SAUDI ARABIA
THROUGH THE SAUDI FUND FOR
DEVELOPMENT (SFD)



LEGEND:

FOR TENDER ONLY



SYM.			NAME		
GRAPHIC SCALE					
NO	DATE	ENG	REVISIONS		

CLIENT:


EMPLOYER:

UNITED NATIONS RELIEF AND WORKS AGENCY
(UNRWA) THROUGH UNITED NATIONS
DEVELOPMENT PROGRAMME (UNDP/PAPP)







CONSULTANT:

PROJECT TITLE:
Reconstruction and repair works of more
than 150 effected houses for non-refugees
and Rehabilitation and Furniture for field
playgrounds and a culture center.

DRAWING TITLE :			
Toilet Block In Beit Hanoun play ground			
PREPARED BY	SCALE	DRAWING NO.	
CHECKED BY	APPROVED BY	Arc-01	
DRAWN BY	DATE	SERIAL NO.	

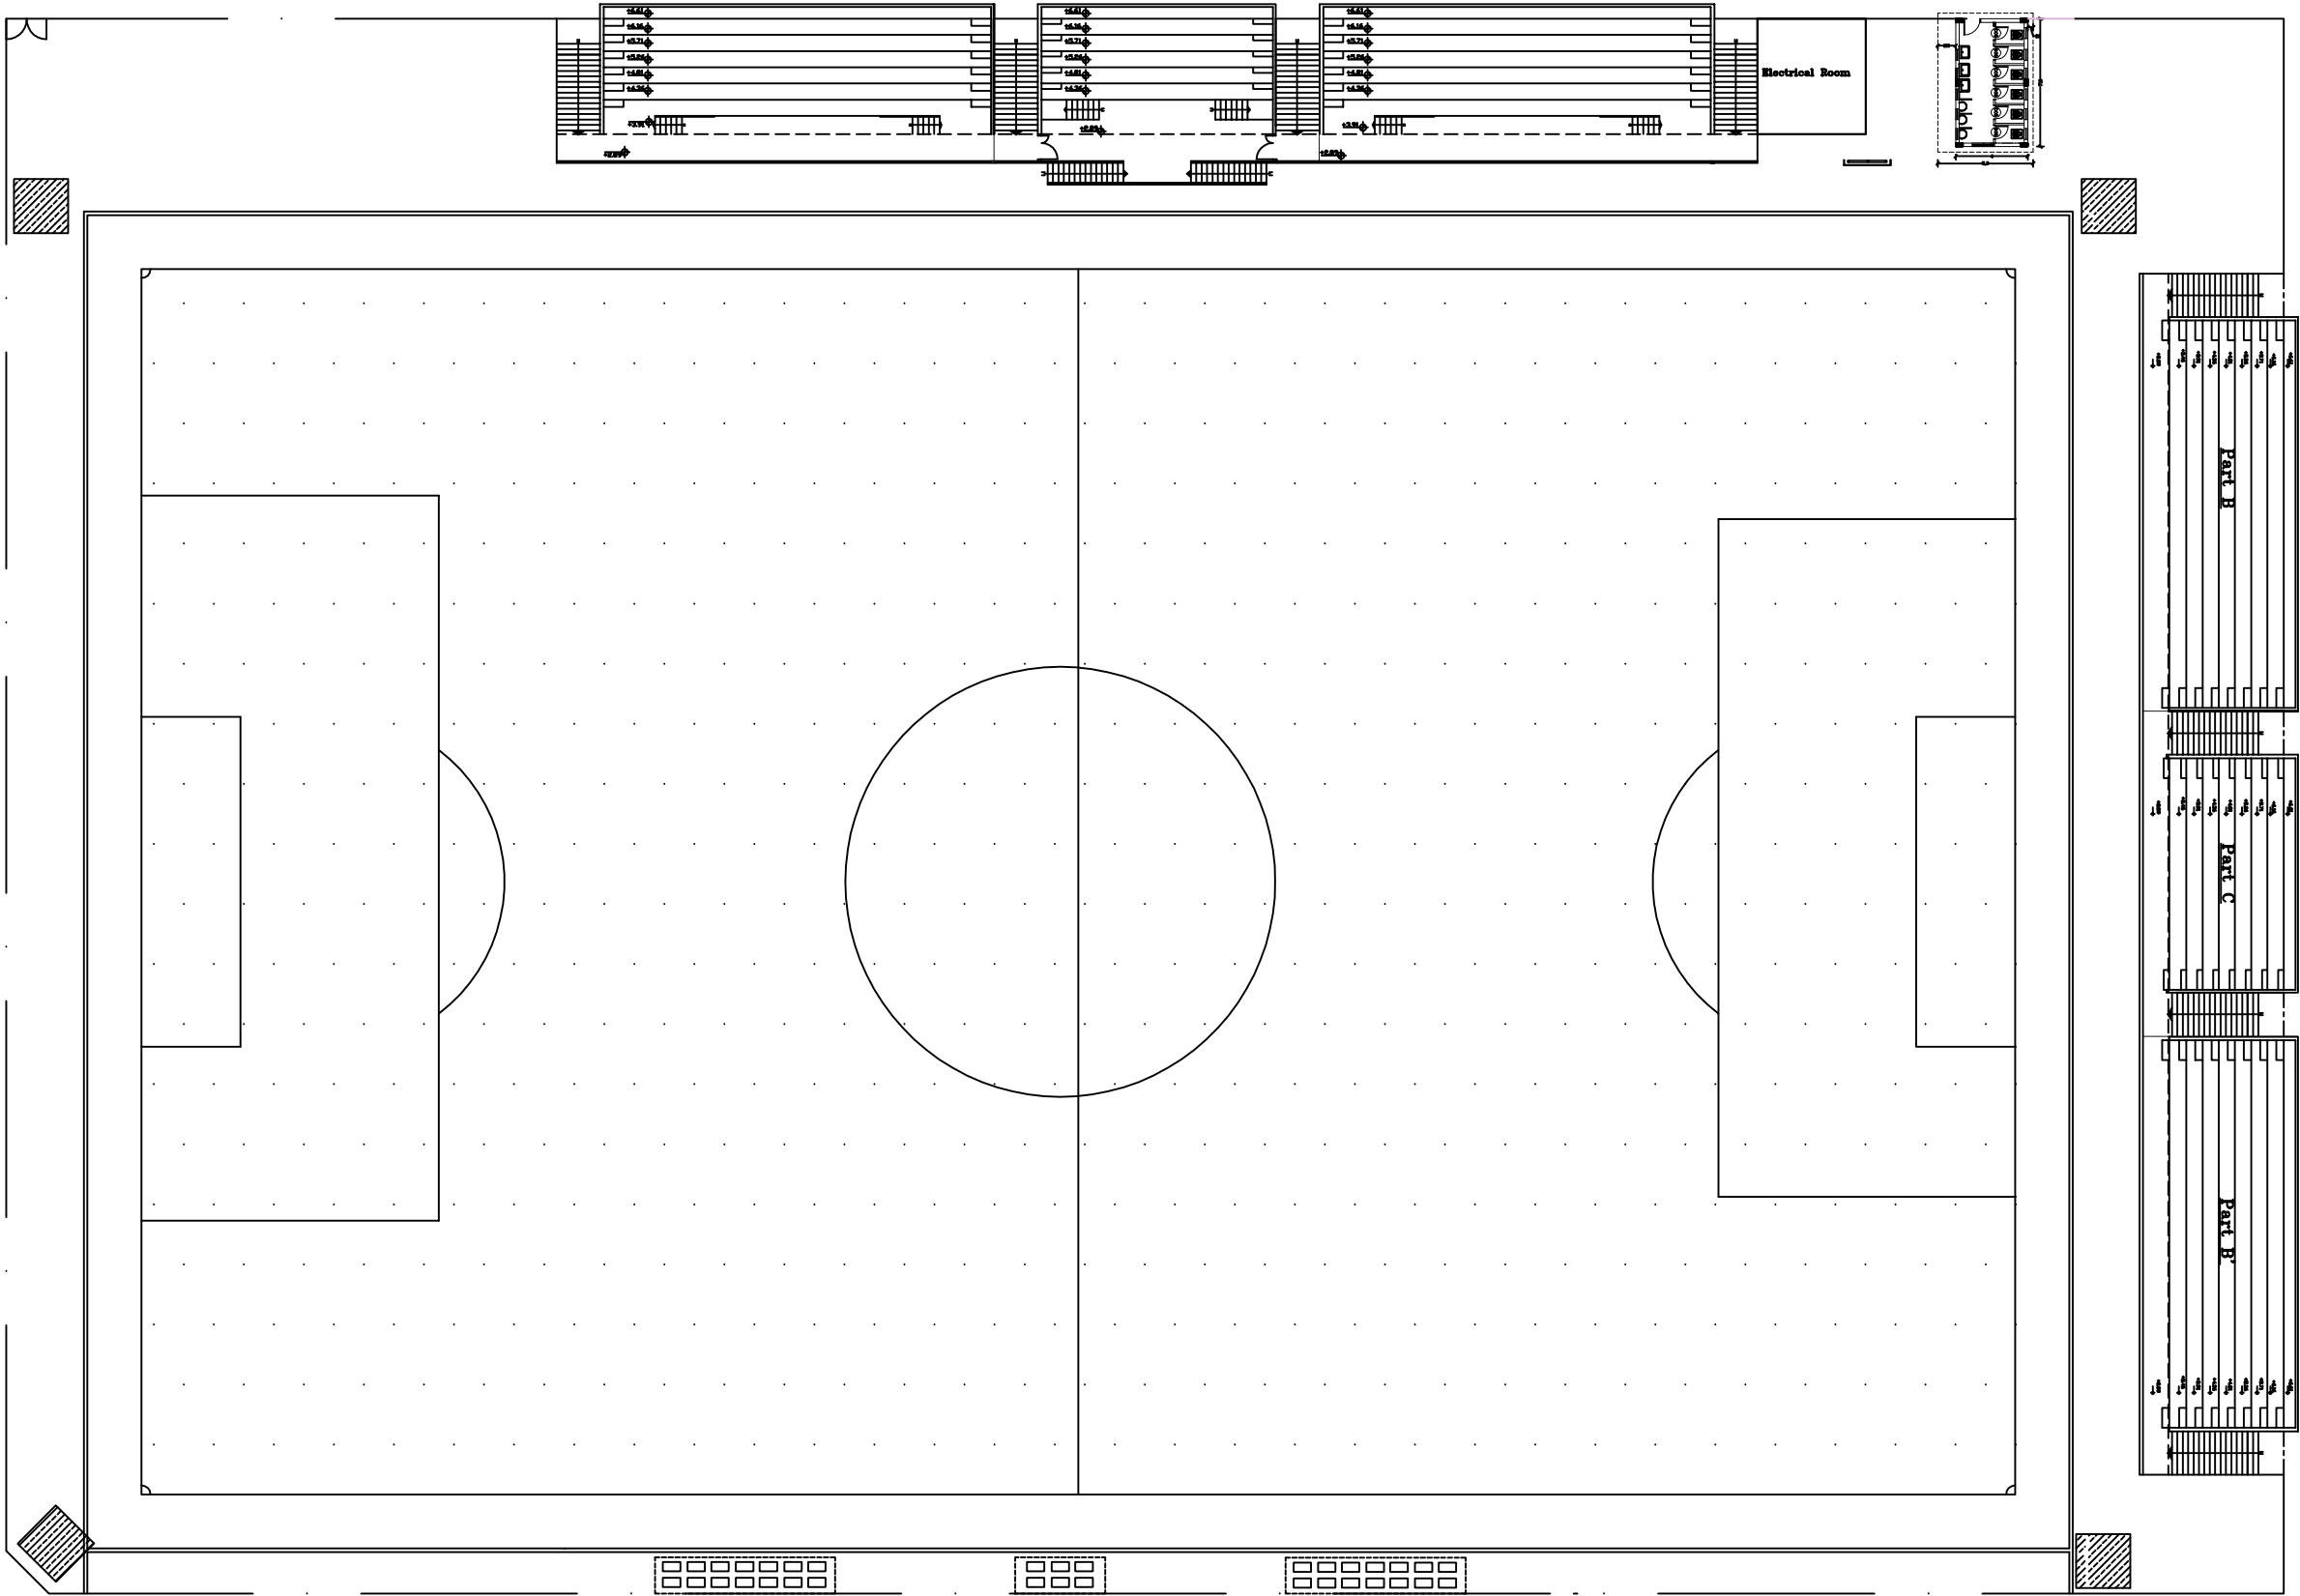

Beit Hanoun play ground

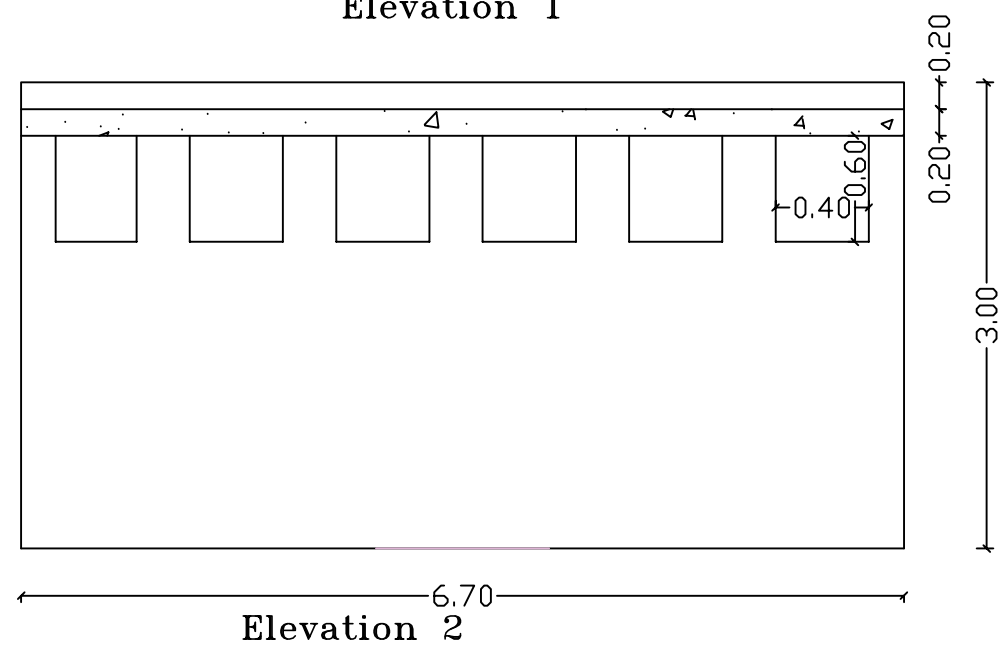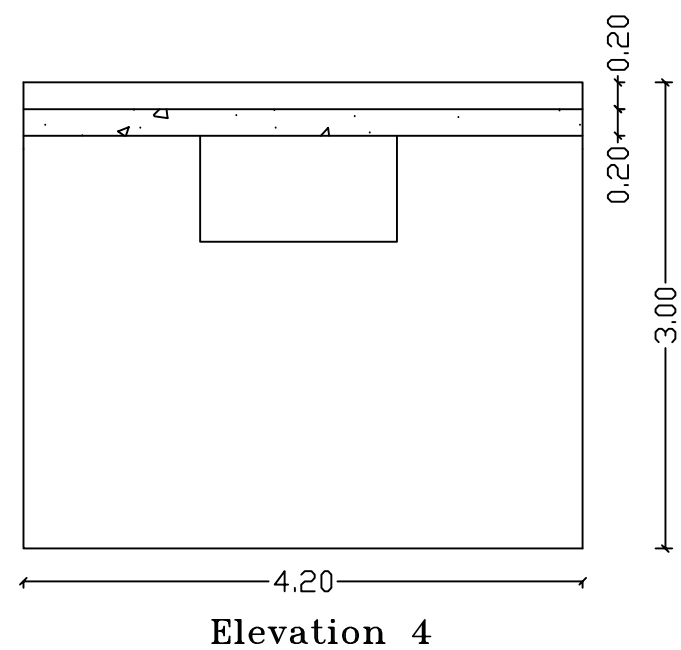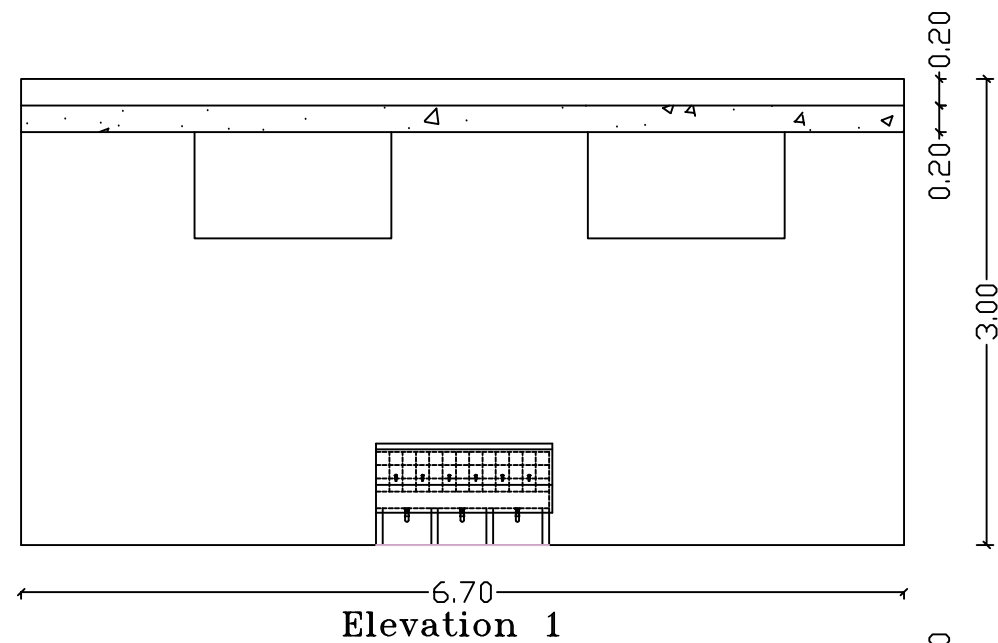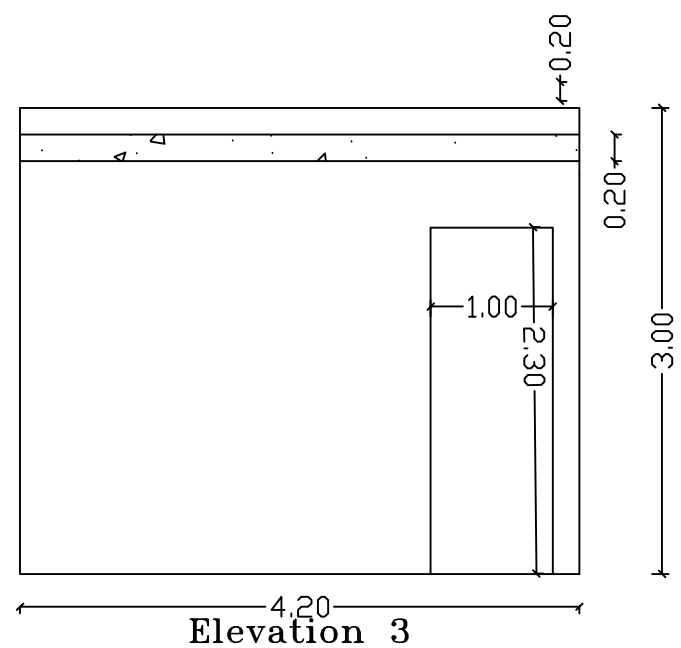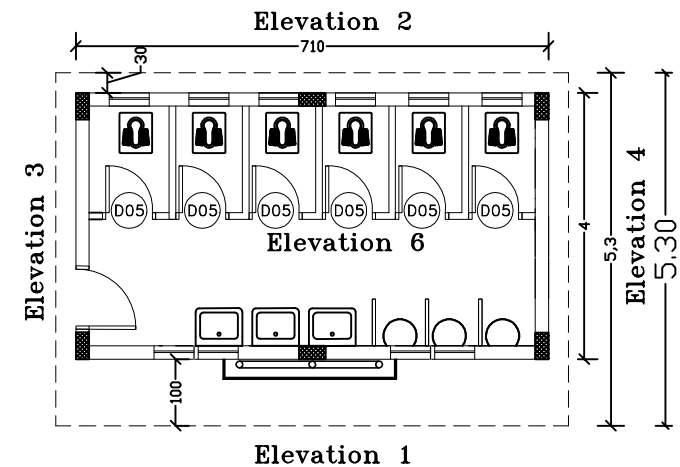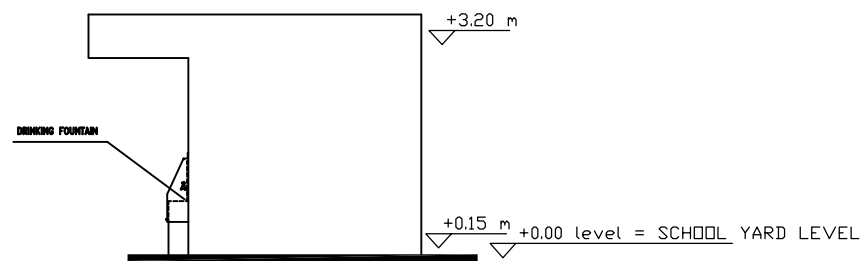


FUNDED BY :
THE KINGDOM OF SAUDI ARABIA
THROUGH THE SAUDI FUND FOR
DEVELOPMENT (SFD)



LEGEND:

FOR TENDER ONLY



SYM.			NAME	
GRAPHIC SCALE				
				
NO	DATE	ENG	REVISIONS	

CLIENT:

EMPLOYER:


UNITED NATIONS RELIEF AND WORKS AGENCY
(UNRWA) THROUGH UNITED NATIONS
DEVELOPMENT PROGRAMME (UNDP/PAPP)

CONSULTANT:


PROJECT TITLE:

Reconstruction and repair works of more
than 150 effected houses for non-refugees
and Rehabilitation and Furniture for field
playgrounds and a culture center.


DRAWING TITLE :			
Toilet Block In Beit Hanoun playground			
PREPARED BY	SCALE	DRAWING NO.	
CHECKED BY	APPROVED BY	D-04	
DRAWN BY	DATE	SERIAL NO.	

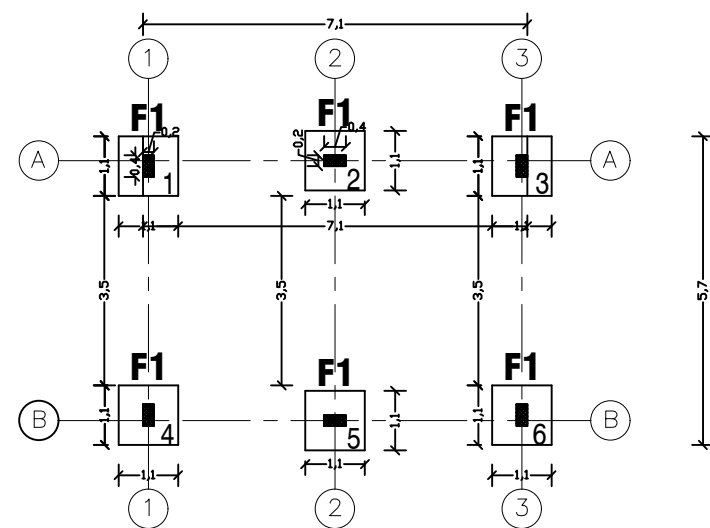

FOUNDATIONS PLAN

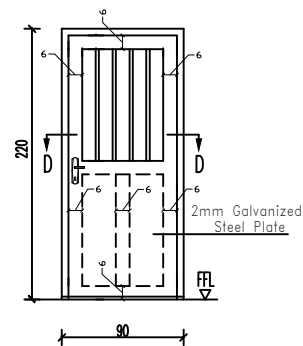

DS1

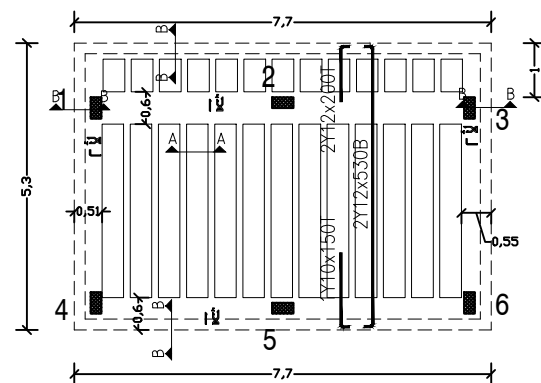





GROUND FLOOR SLAB

FOUNDATIONS TABLE


TYPE	COLUMNS	NO.	A*B*H(m)	LONG STEEL	SHORT STEEL	NOTES
F1	1,2,3,4, 5,6	6	1.1*1.1*.40m	6Ø12	6Ø12	

COLUMNS TABLE


TYPE	COLUMNS	NO.	Pedestals	Ground Floor	Notes
15	1,2,3,4, 5,6	6			-

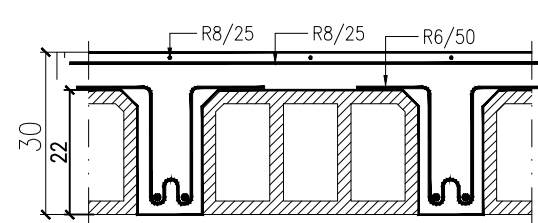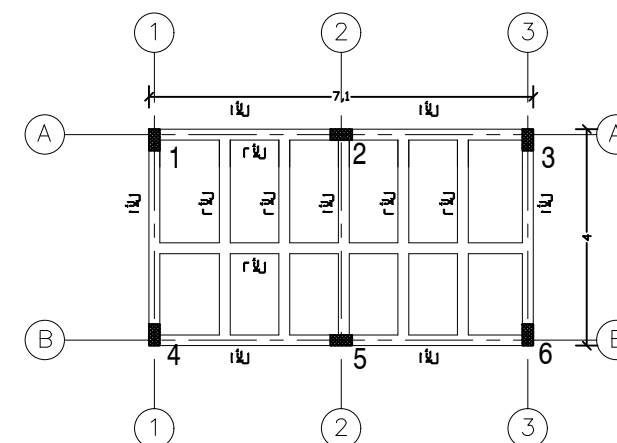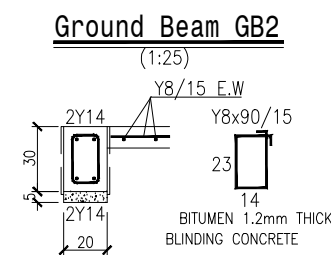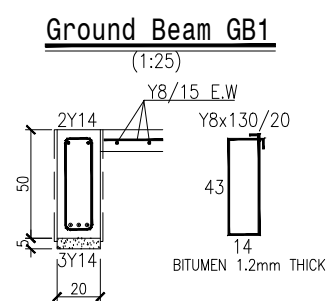

Section (A-A)

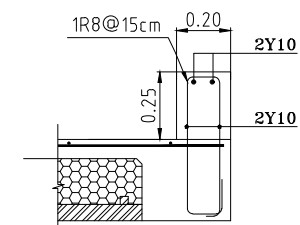

Section (B-B)

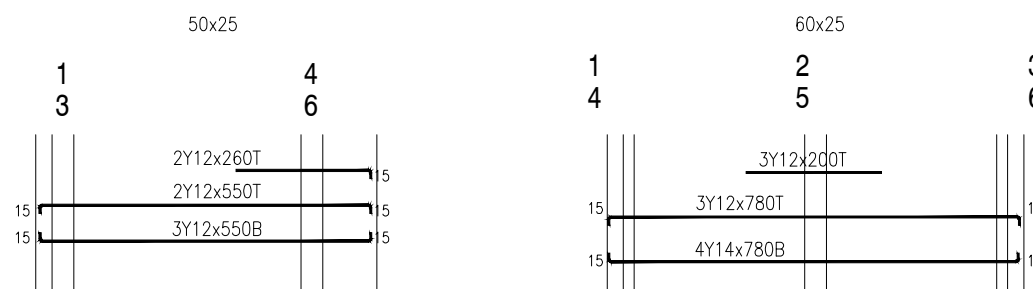


**THE KINGDOM OF SAUDI ARABIA
THROUGH THE SAUDI FUND FOR
DEVELOPMENT (SFD)**



LEGEND:

FOR TENDER ONLY



SYM.			NAME		
GRAPHIC SCALE 					
NO	DATE	ENG	REVISIONS		

CLIENT:

EMPLOYER:

UNITED NATIONS RELIEF AND WORKS AGENCY
(UNRWA) THROUGH UNITED NATIONS
DEVELOPMENT PROGRAMME (UNDP/PAPP)

CONSULTANT:


PROJECT TITLE:

Reconstruction and repair works of more than 150 effected houses for non-refugees and Rehabilitation and Furniture for field playgrounds and a culture center.

DRAWING TITLE :

Toilet Block In Beit Hanoun play ground

PREPARED BY	SCALE	DRAWING NO. D-05
CHECKED BY	APPROVED BY	
DRAWN BY	DATE	SERIAL NO.

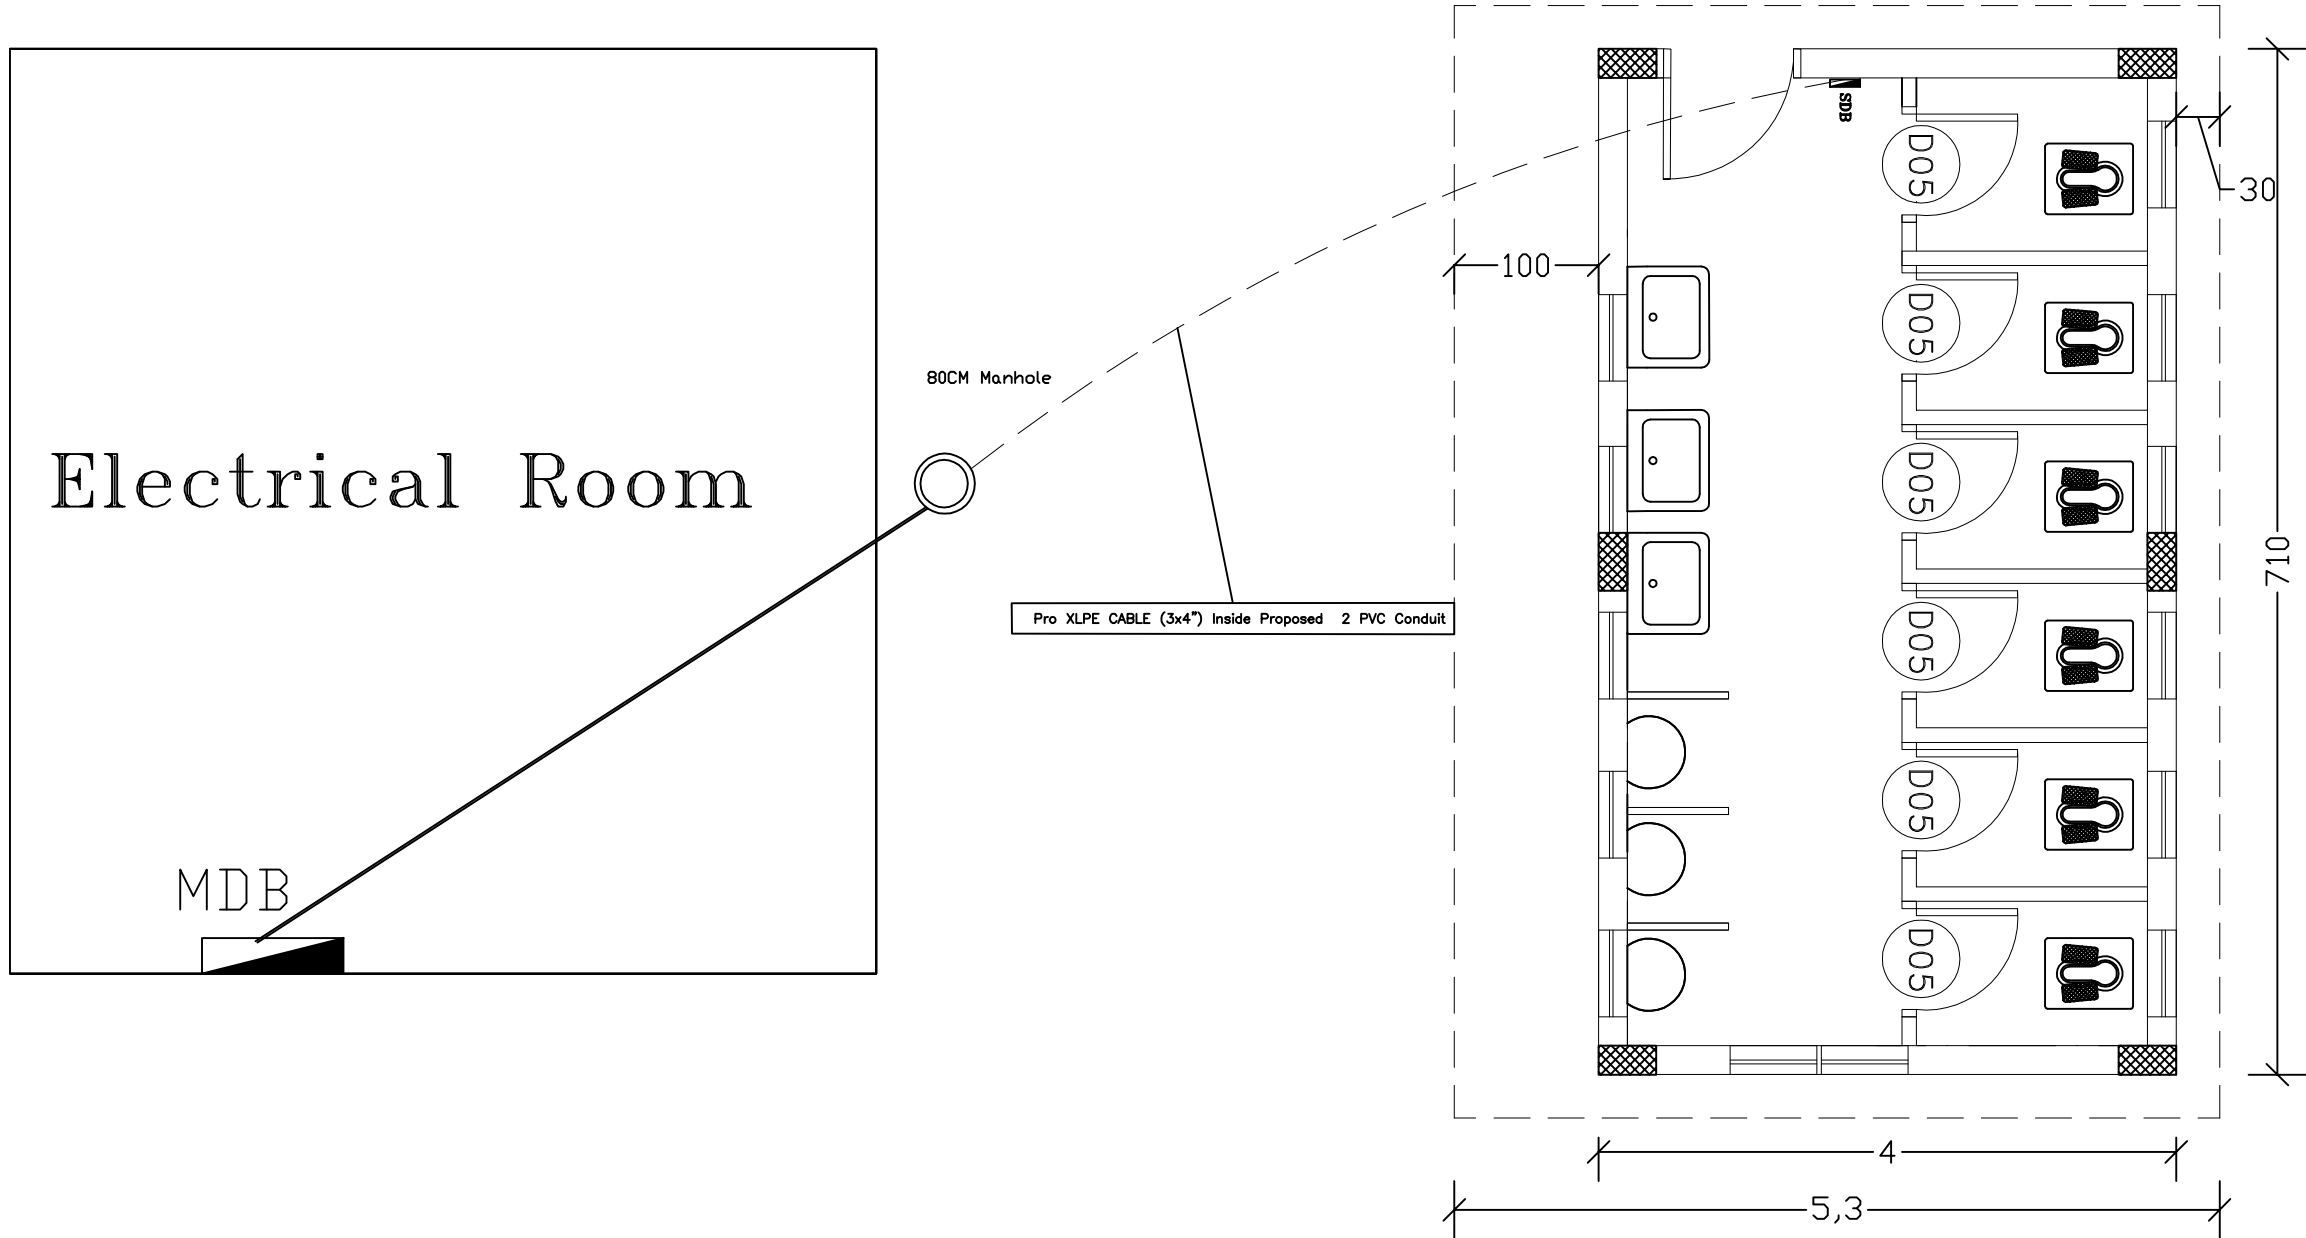

Electrical Site Layout




FUNDED BY :
THE KINGDOM OF SAUDI ARABIA
THROUGH THE SAUDI FUND FOR
DEVELOPMENT (SFD)



LEGEND:

FOR TENDER ONLY



SYM.			NAME		
GRAPHIC SCALE					
NO	DATE	ENG	REVISIONS		

CLIENT:

EMPLOYER:

UNITED NATIONS RELIEF AND WORKS AGENCY
(UNRWA) THROUGH UNITED NATIONS
DEVELOPMENT PROGRAMME (UNDP/PAPP)

CONSULTANT:

PROJECT TITLE:

Reconstruction and repair works of more
than 150 effected houses for non-refugees
and Rehabilitation and Furniture for field
playgrounds and a culture center.

Lot#10-B:Construction of the External Toilet
Unit

DRAWING TITLE :			
Toilet Block In Beit Hanoun play ground			
PREPARED BY	SCALE	DRAWING NO.	
CHECKED BY	APPROVED BY	E-05	
DRAWN BY	DATE	SERIAL NO.	




FUNDED BY :
THE KINGDOM OF SAUDI ARABIA
THROUGH THE SAUDI FUND FOR
DEVELOPMENT (SFD)



LEGEND:

FOR TENDER ONLY



SYM.		NAME	
GRAPHIC SCALE			
NO	DATE	ENG	REVISIONS

CLIENT:

EMPLOYER:

UNITED NATIONS RELIEF AND WORKS AGENCY
(UNRWA) THROUGH UNITED NATIONS
DEVELOPMENT PROGRAMME (UNDP/PAPP)


CONSULTANT:

PROJECT TITLE:





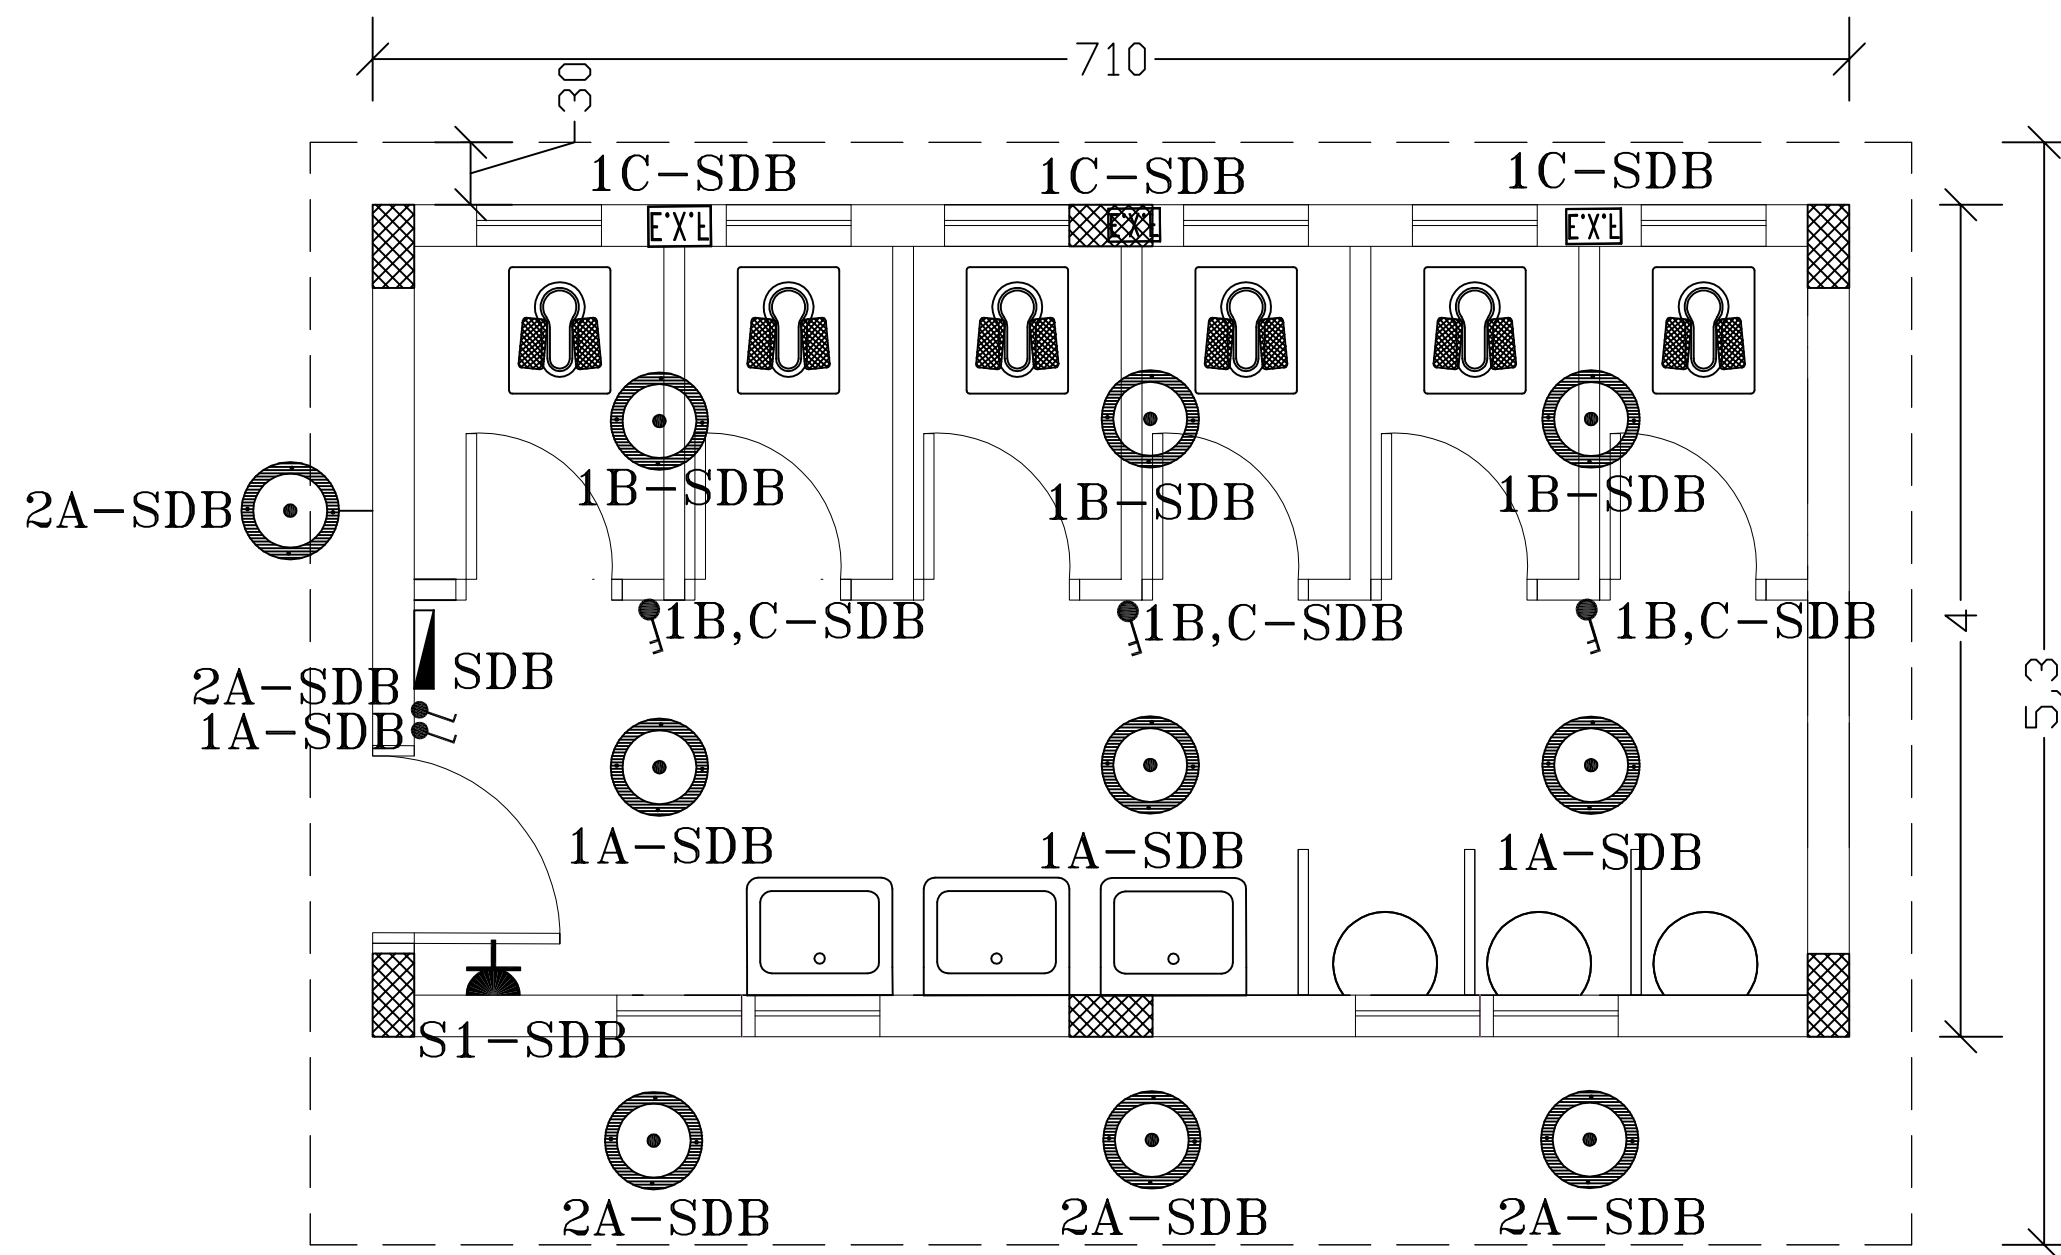

Reconstruction and repair works of more
than 150 effected houses for non-refugees
and Rehabilitation and Furniture for field
playgrounds and a culture center.

Lot#10-B:Construction of the External Toilet
Unit


DRAWING TITLE:			
Toilet Block In Beit Hanoun play ground			
PREPARED BY	SCALE	DRAWING NO.	
CHECKED BY	APPROVED BY	E-05	
DRAWN BY	DATE	SERIAL NO.	



LEGEND:


-  SUB DISTRIBUTION BOARD
-  ONE GANG, ONE WAY SWITCH, WITH IP-55 WATER TIGHT PLATE.
-  Two GANG, ONE WAY SWITCH, WITH IP-55 WATER TIGHT PLATE.
-  1x16A - 220V WATER TIGHT ELECTRICAL SOCKET.
-  SURFACE MOUNTED LED GLOBE, 14WATT
-  Extract FAN 6 INCH

Lighting & Power system plan

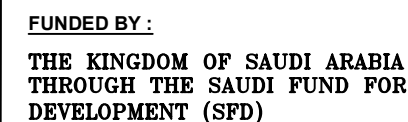

FOR TENDER ONLY



SYM.		NAME	
GRAPHIC SCALE 			
NO	DATE	ENG	REVISIONS

CLIENT:

EMPLOYER:

UNITED NATIONS RELIEF AND WORKS AGENCY
(UNRWA) THROUGH UNITED NATIONS
DEVELOPMENT PROGRAMME (UNDP/PAPP)

CONSULTANT:


PROJECT TITLE:

Reconstruction and repair works of more than 150 effected houses for non-refugees and Rehabilitation and Furniture for field playgrounds and a culture center.

Lot#10-B: Construction of the External Toilet Unit




<p><u>DRAWING TITLE :</u></p> <p>Steel Protection Windows Details</p>	<p>DATE : _____</p>
	<p>BY : _____</p>

PREPARED BY	SCALE	DRAWING NO. Arc-01
CHECKED BY	APPROVED BY	
DRAWN BY	DATE	SERIAL NO.


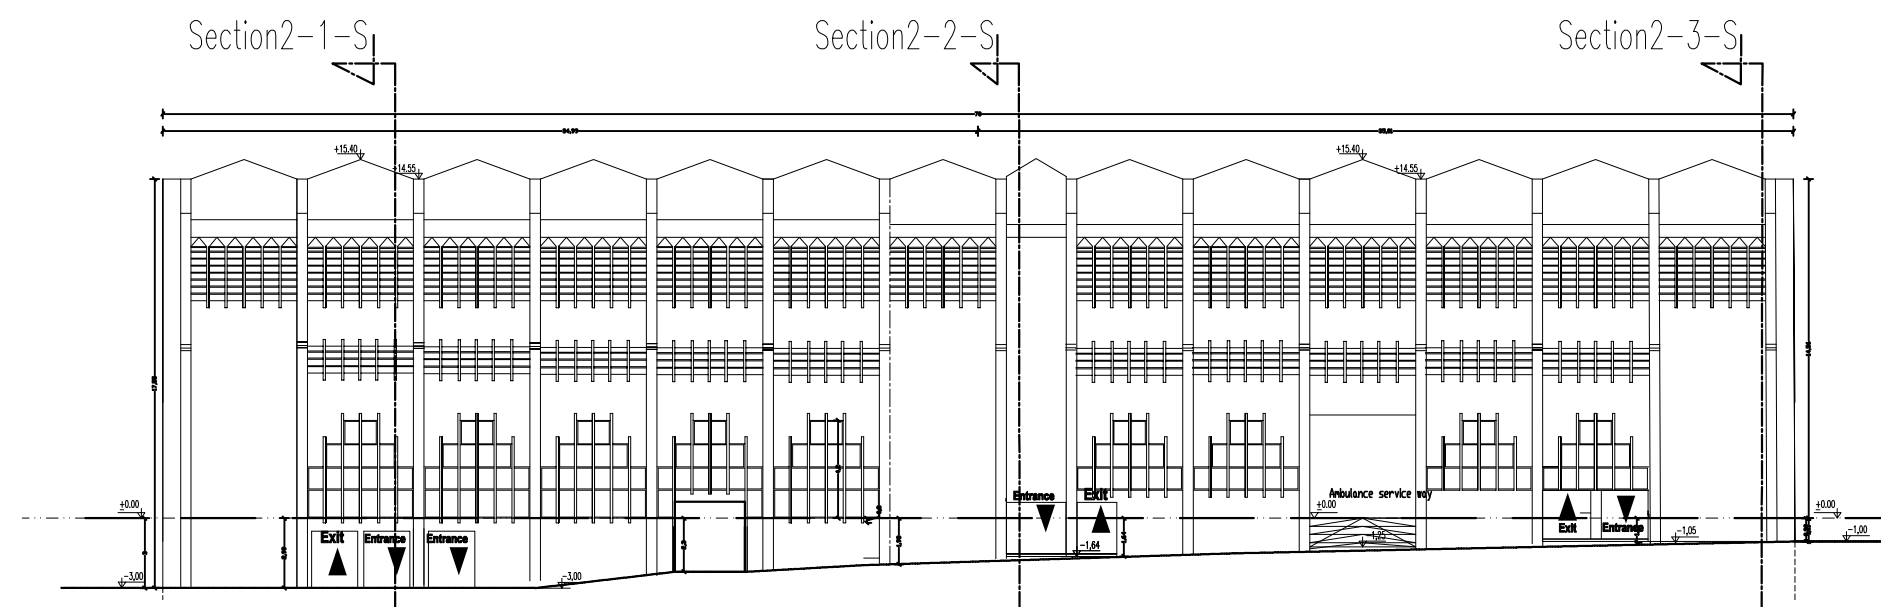


South Elevation

DETAIL A

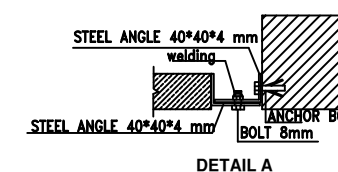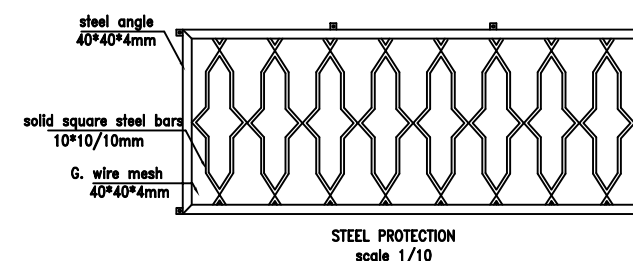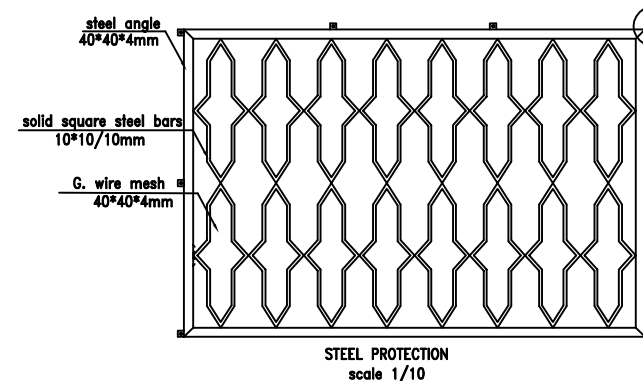


حمايات الشبابيك

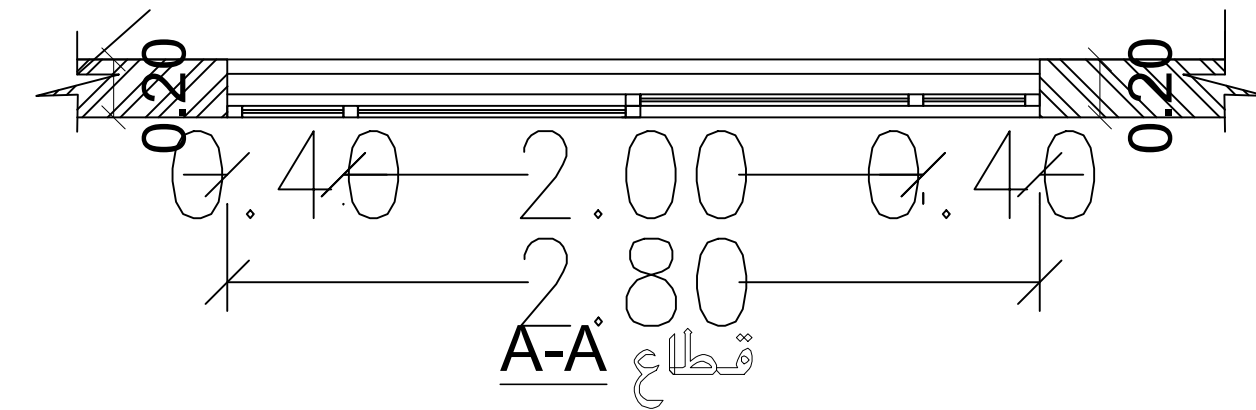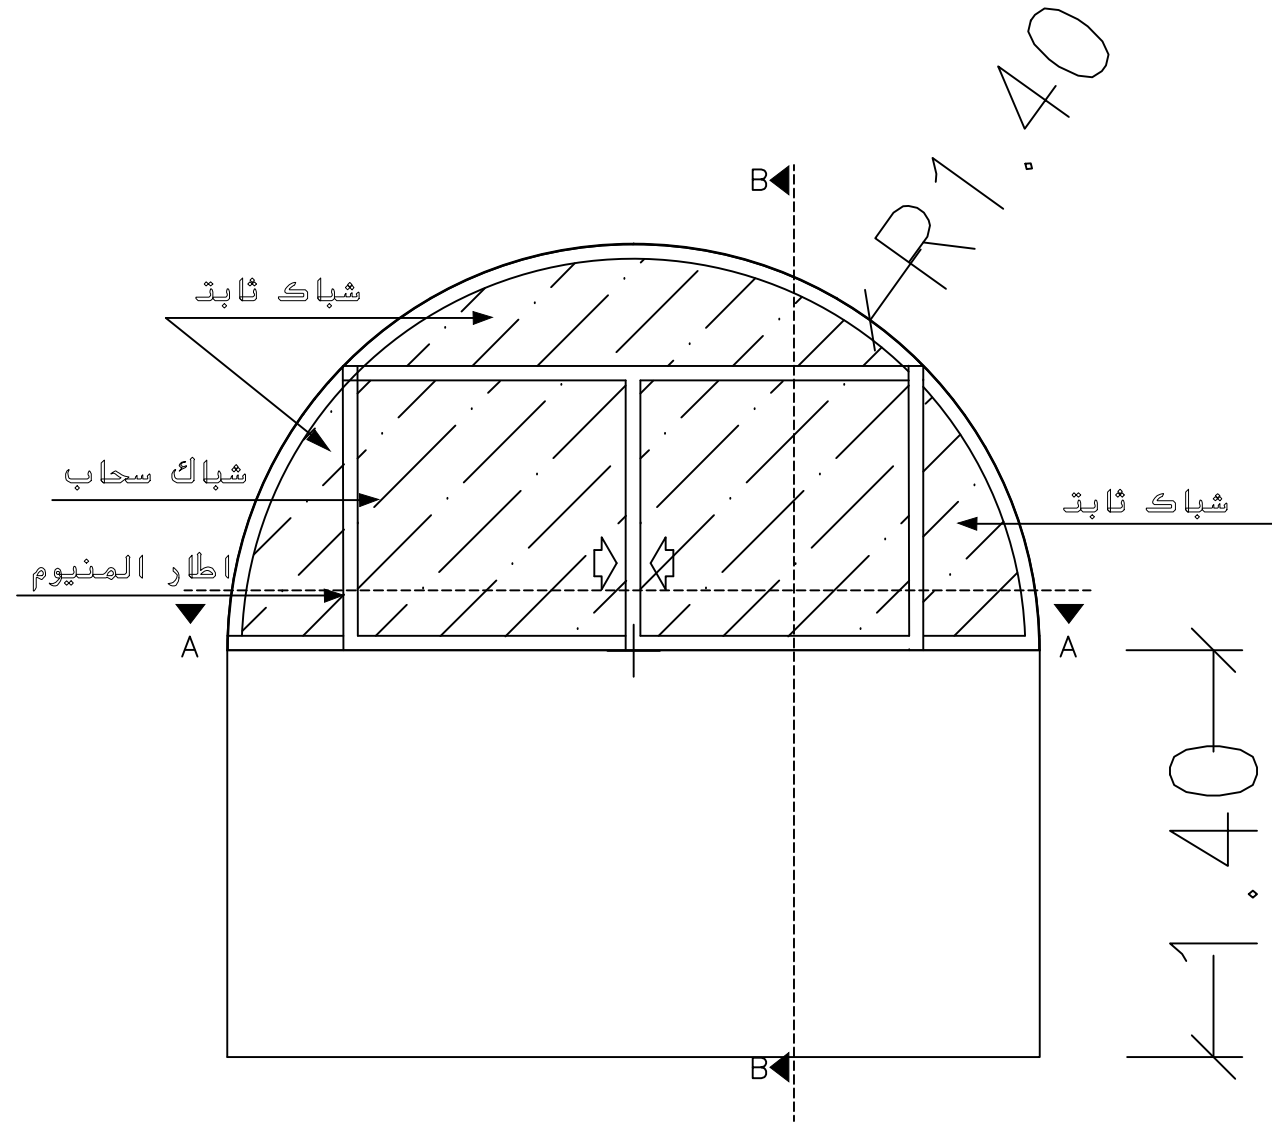

FUNDED BY :
THE KINGDOM OF SAUDI ARABIA
THROUGH THE SAUDI FUND FOR
DEVELOPMENT (SFD)



General Notes

SYM.		NAME	
GRAPHIC SCALE			
			
NO	DATE	ENG	REVISIONS






EMPLOYER:
UNITED NATIONS RELIEF AND WORKS AGENCY
(UNRWA) THROUGH UNITED NATIONS
DEVELOPMENT PROGRAMME (UNDP/PAPP)

CONSULTANT:

PROJECT TITLE:
Reconstruction and repair works of more
than 150 effected houses for non-refugees
and Rehabilitation and Furniture for field
playgrounds and a culture center.
Lot#5: Reconstruction the Southern grand
stand in Alyarmouk playground

DRAWING TITLE :		
PREPARED BY	SCALE	DRAWING NO.
CHECKED BY	APPROVED BY	
DRAWN BY	DATE	SERIAL NO.

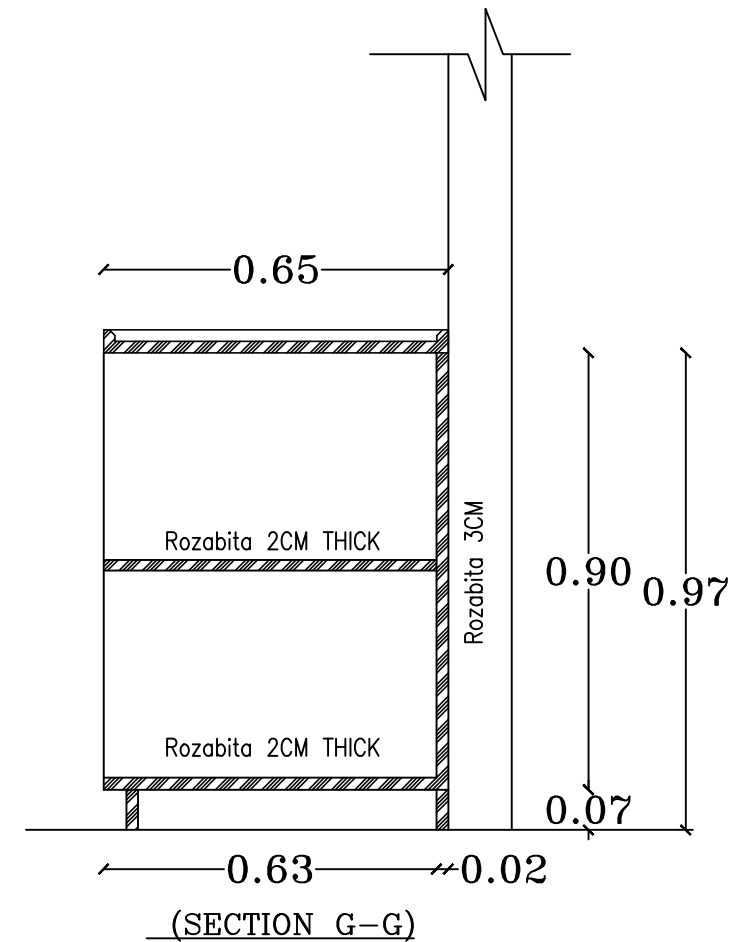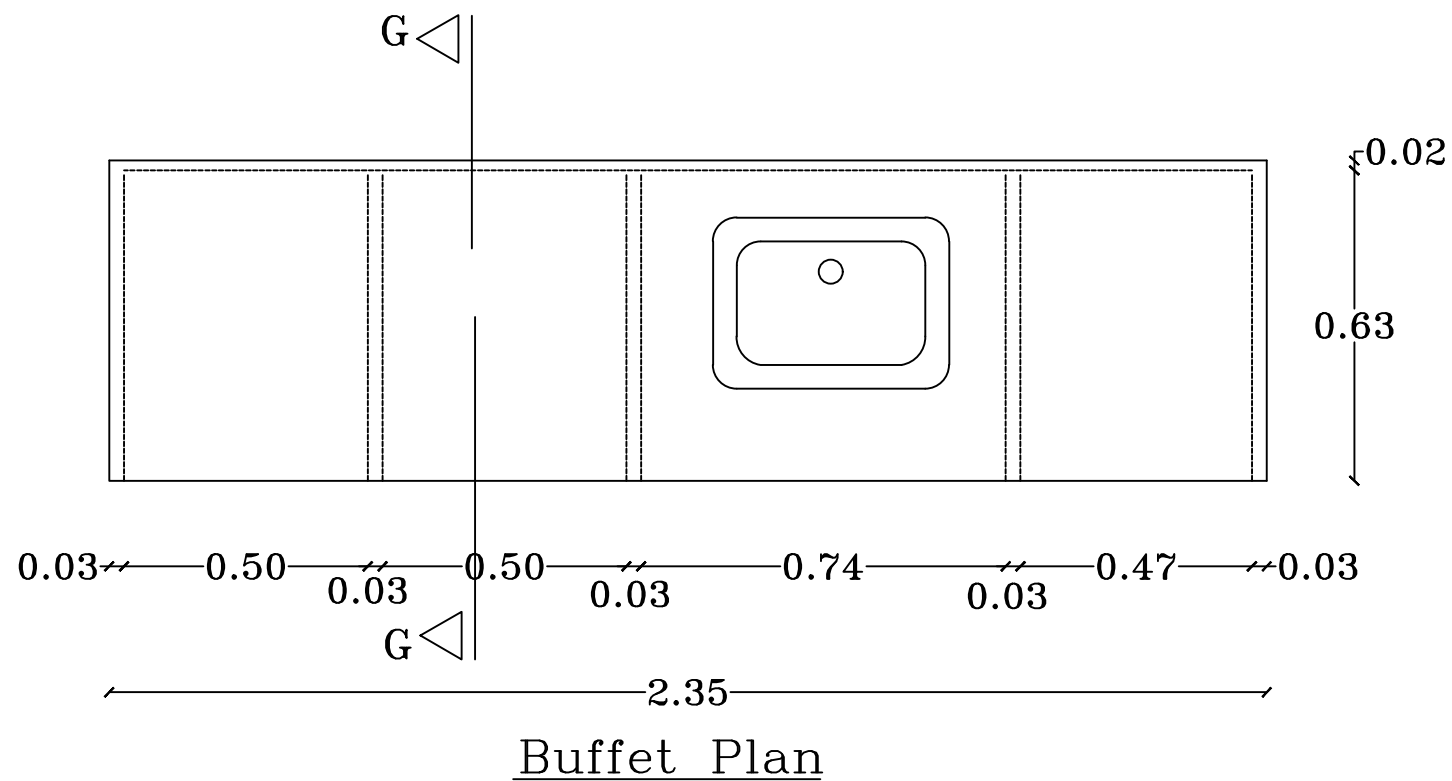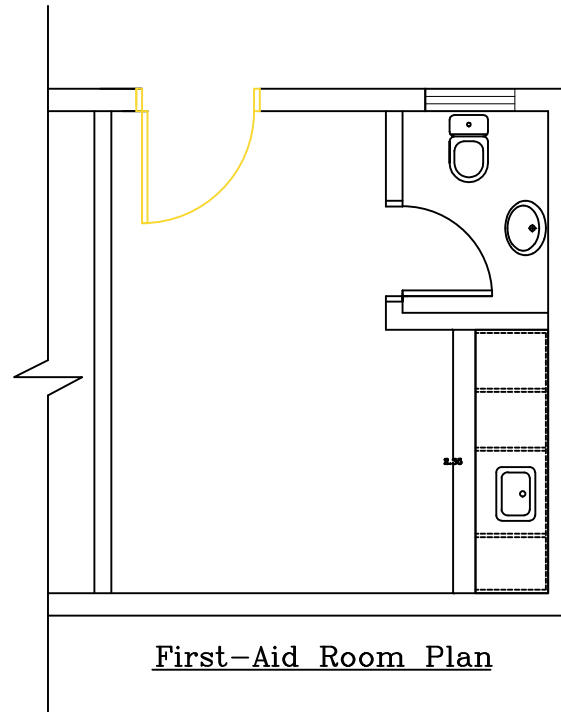

FUNDED BY :
THE KINGDOM OF SAUDI ARABIA
THROUGH THE SAUDI FUND FOR
DEVELOPMENT (SFD)



General Notes

SYM.	NAME
GRAPHIC SCALE 0 1 2 3 4	

NO	DATE	ENG	REVISIONS
----	------	-----	-----------



EMPLOYER:
UNITED NATIONS RELIEF AND WORKS AGENCY
(UNRWA) THROUGH UNITED NATIONS
DEVELOPMENT PROGRAMME (UNDP/PAPP)



CONSULTANT:

PROJECT TITLE:
Reconstruction and repair works of more
than 150 effected houses for non-refugees
and Rehabilitation and Furniture for field
playgrounds and a culture center.

Lot#5: Reconstruction the Southern grand
stand in Alyarmouk playground

DRAWING TITLE :

PREPARED BY	SCALE	DRAWING NO.
CHECKED BY	APPROVED BY	
DRAWN BY	DATE	SERIAL NO.

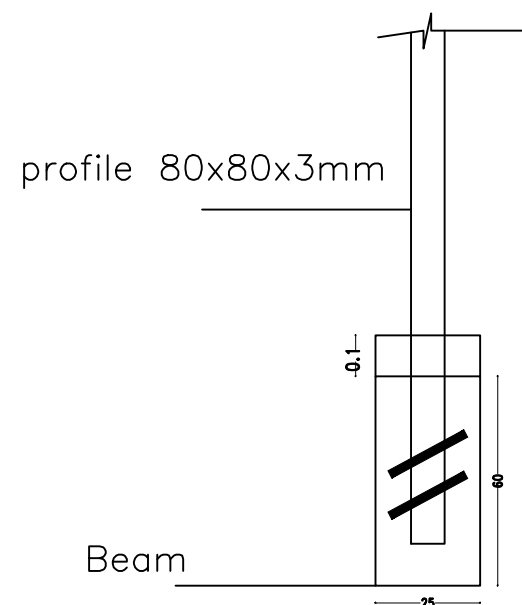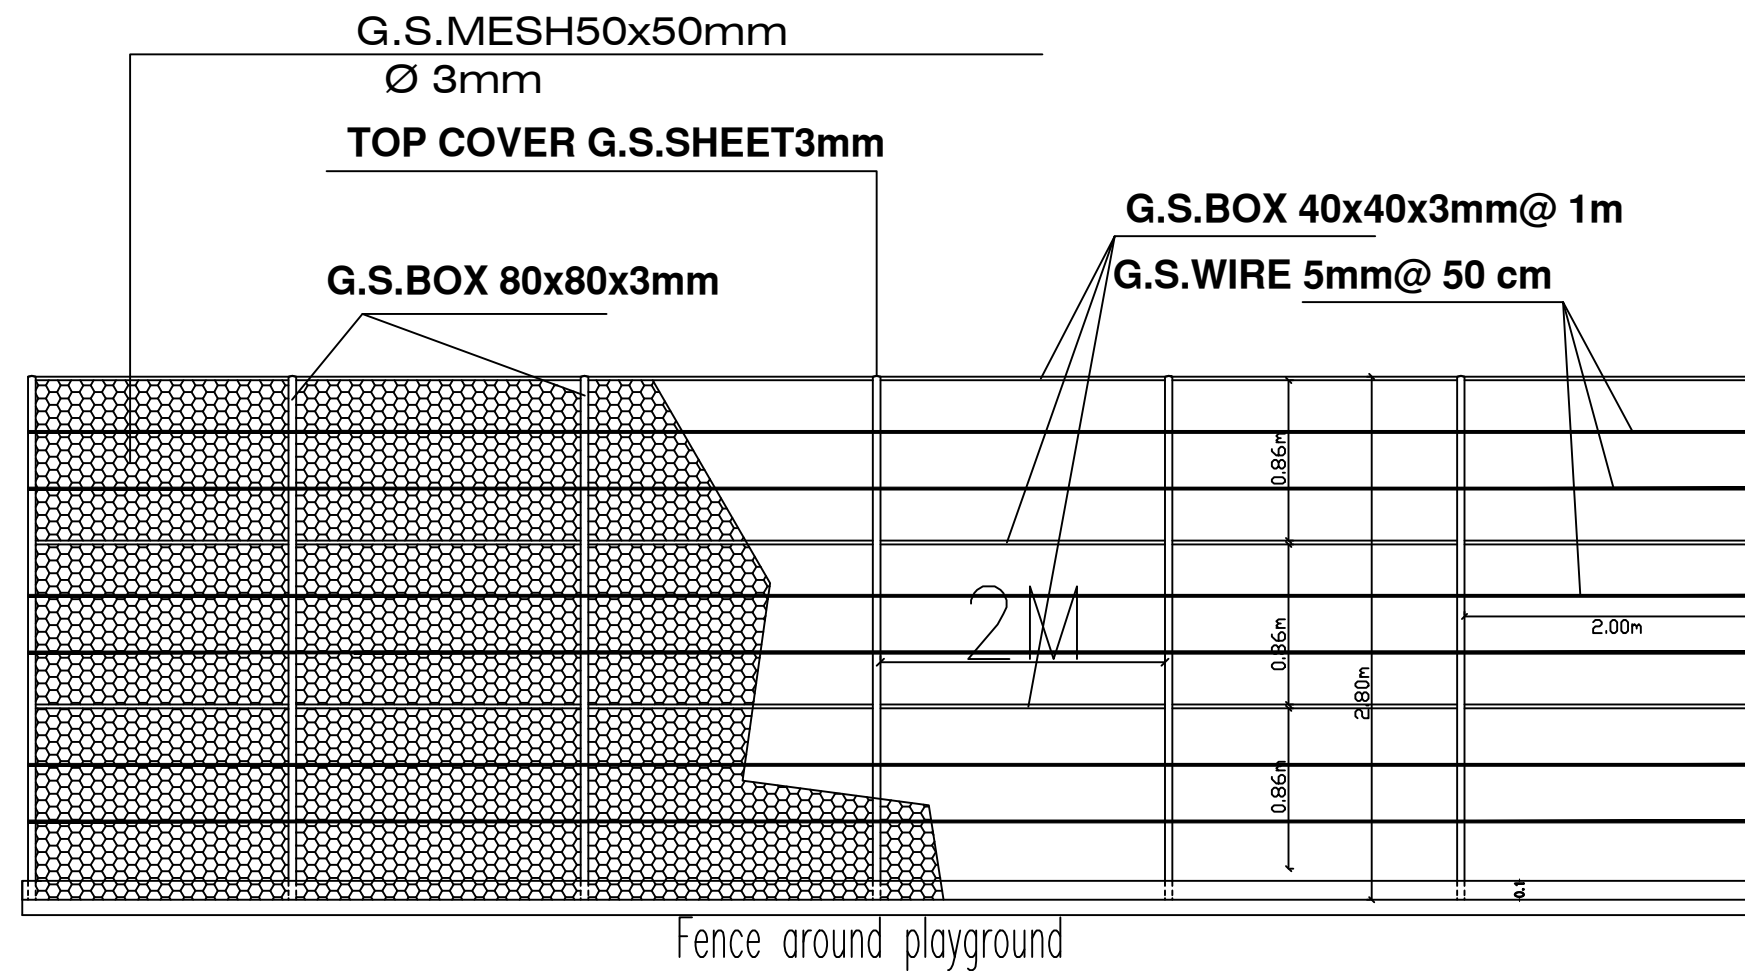

FUNDED BY :
THE KINGDOM OF SAUDI ARABIA
THROUGH THE SAUDI FUND FOR
DEVELOPMENT (SFD)



General Notes

SYM.	NAME
GRAPHIC SCALE 0 1 2 3 4	
NO	DATE
ENG	REVISIONS



EMPLOYER:
UNITED NATIONS RELIEF AND WORKS AGENCY
(UNRWA) THROUGH UNITED NATIONS
DEVELOPMENT PROGRAMME (UNDP/PAPP)

CONSULTANT:

PROJECT TITLE:
Reconstruction and repair works of more
than 150 affected houses for non-refugees
and Rehabilitation and Furniture for field
playgrounds and a culture center.
Lot : #5 Reconstruction the Southern grand
stand in Palestine playground

DRAWING TITLE :

PREPARED BY	SCALE	DRAWING NO.
CHECKED BY	APPROVED BY	
DRAWN BY	DATE	SERIAL NO.