

REVISIONS				
ZONE	REV	DESCRIPTION	DATE	APPROVED

Sebha City Primary School	Two Classrooms Building			
	Ground Floor Plan			
	SIZE	FROM NO.	DWG NO.	REV
	SCALE			SHEET

8 7 6 5 4 3 2 1

REVISIONS				
ZONE	REV	DESCRIPTION	DATE	APPROVED

D

D

C


C

B

B


A

A

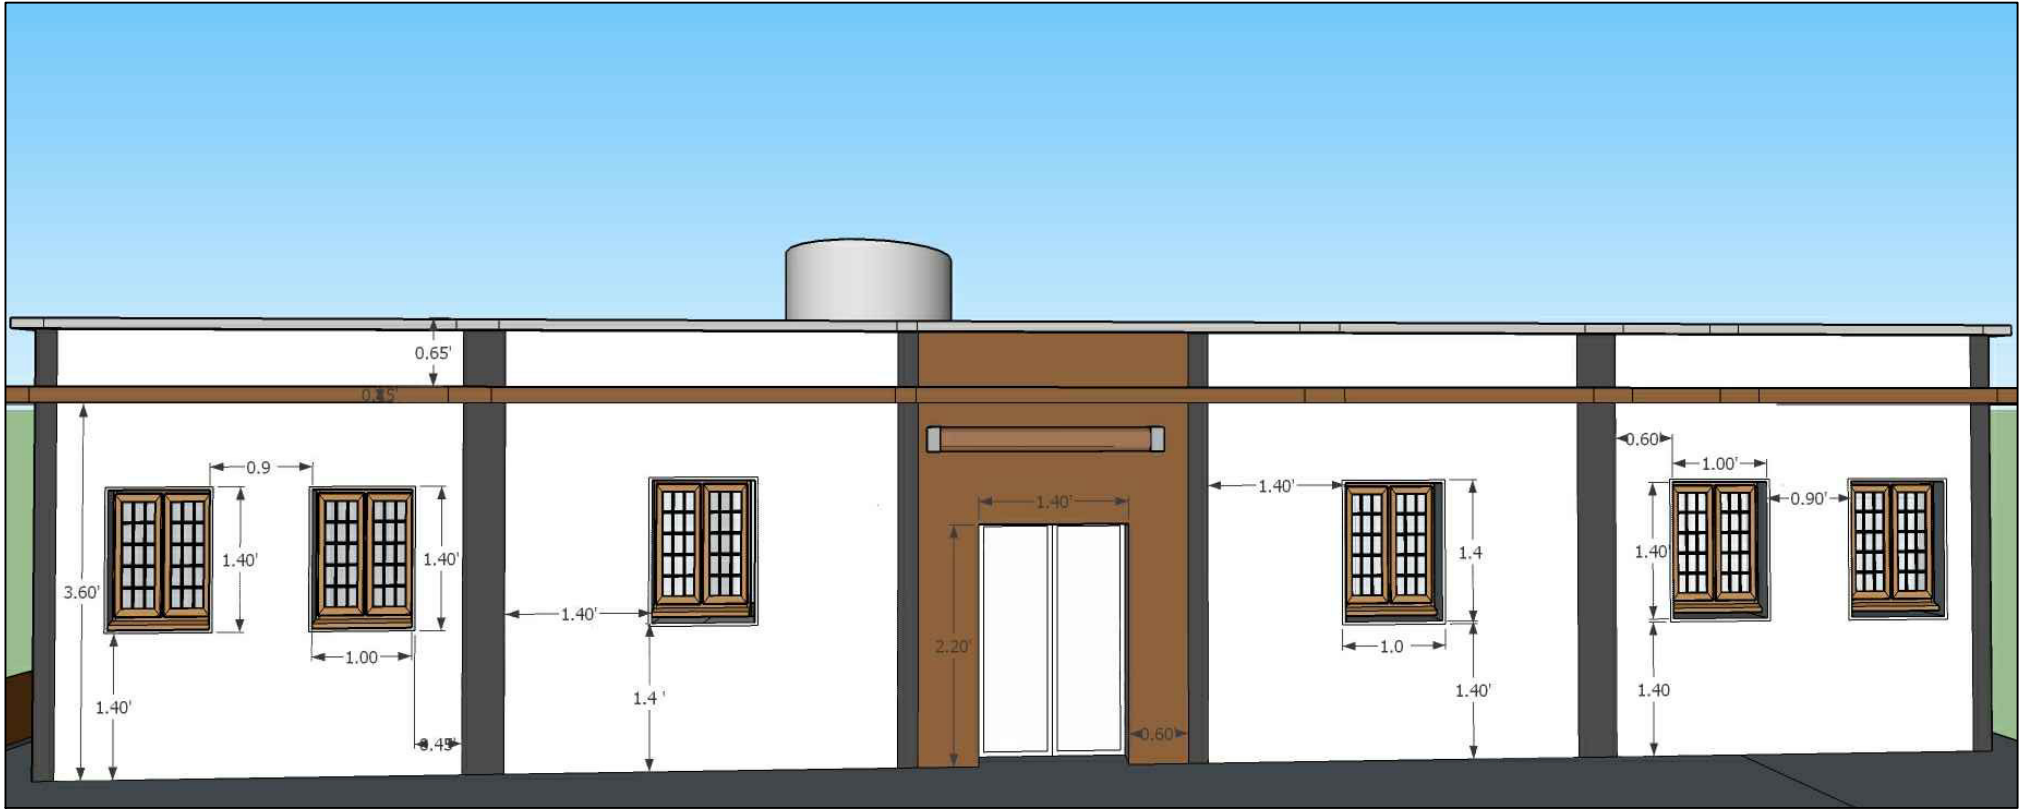


Sebha City Primary School	Two Classrooms Building		
	Front Elevation		
	SIZE FROM NO.	DWG NO.	REV
	SCALE		SHEET

8 7 6 5 4 3 2 1

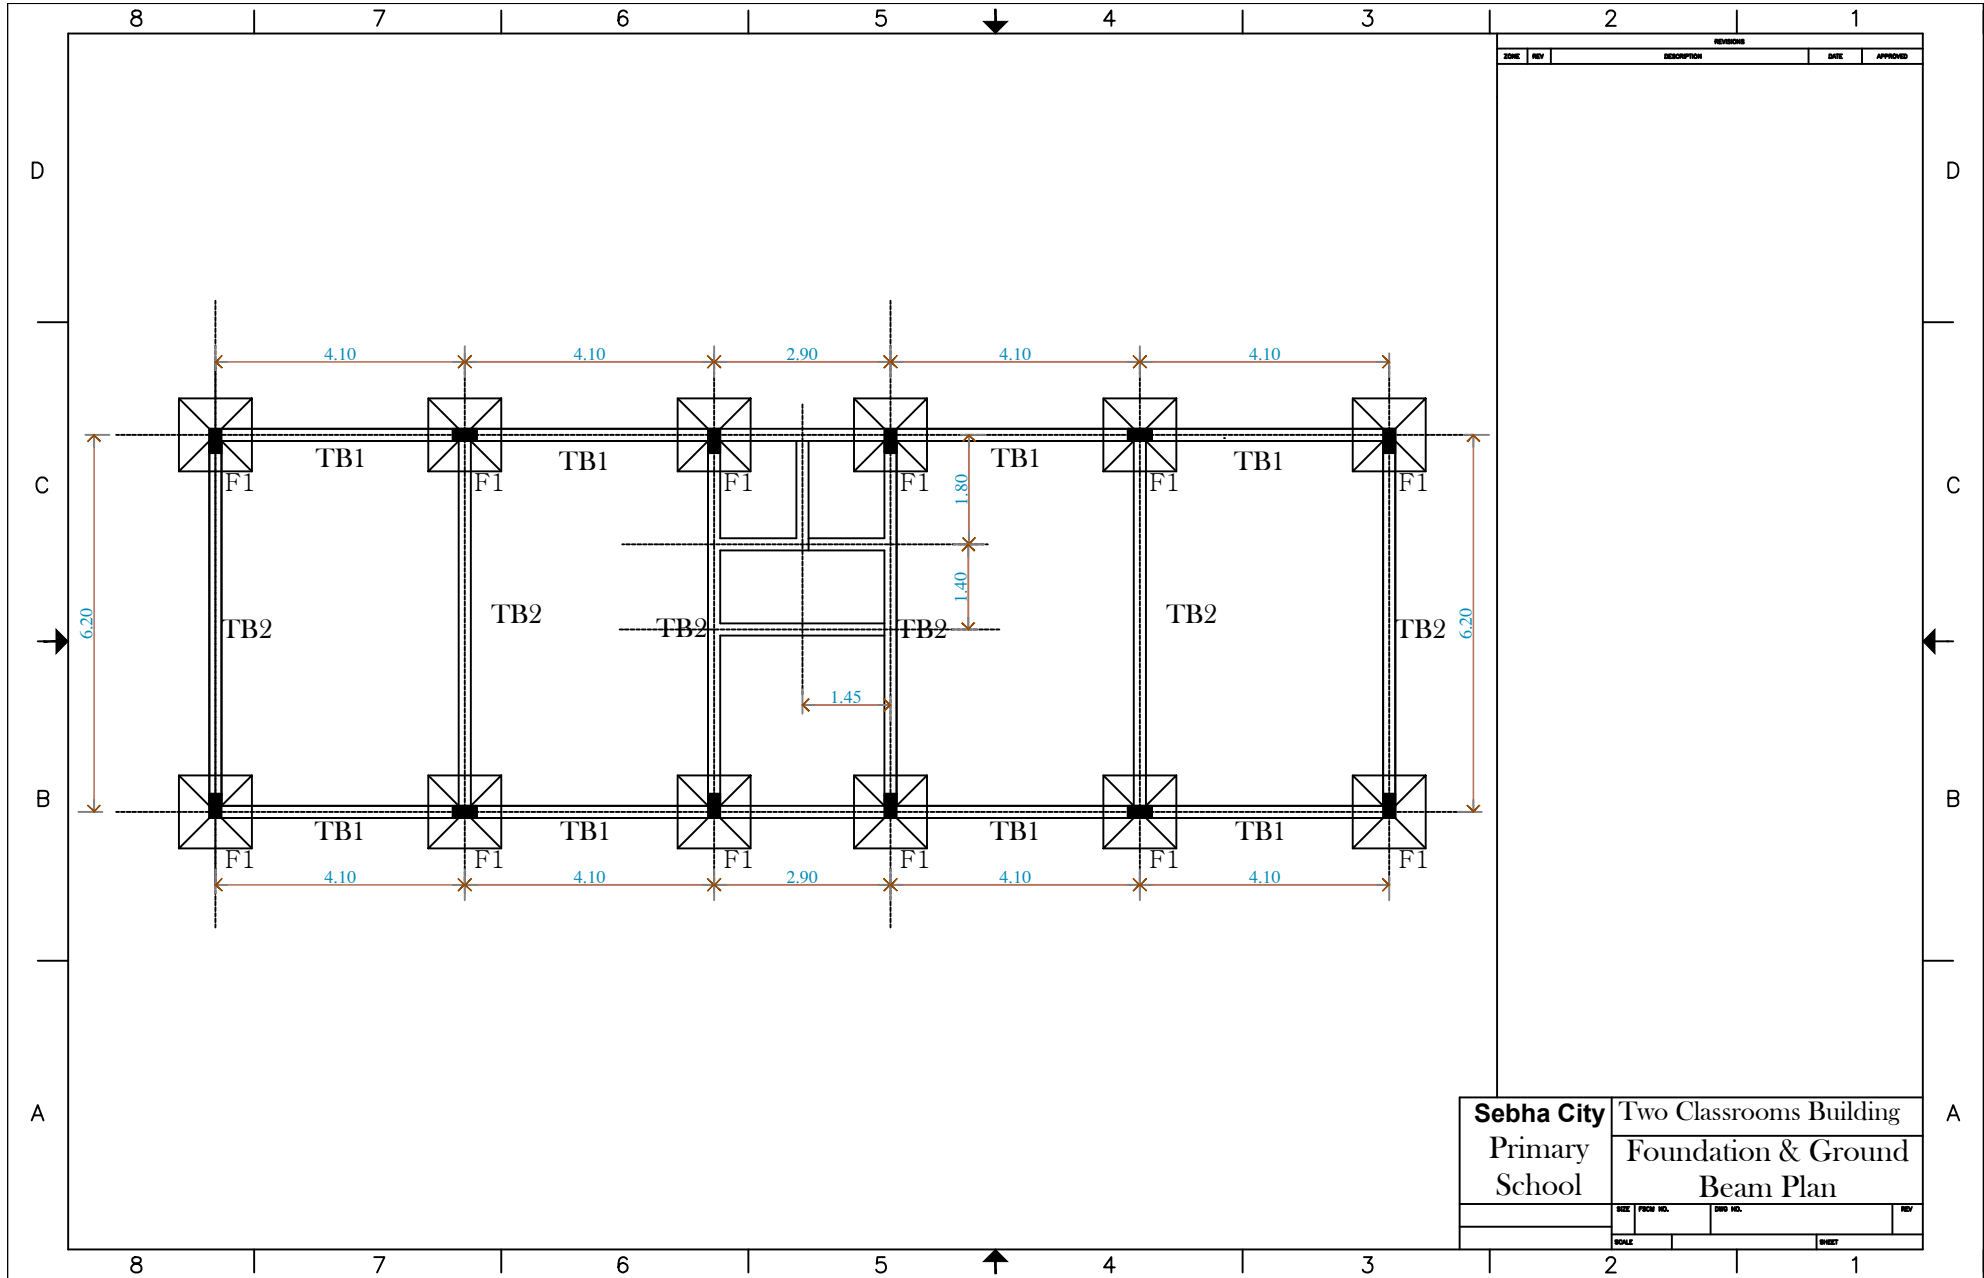


REVISIONS				
NO.	REV.	DESCRIPTION	DATE	APPROVED

Sebha City Primary School	Two Classrooms Building		
	Foundation & Ground Beam Plan		
SCALE	DATE	NO. OF SHEETS	TOTAL SHEETS

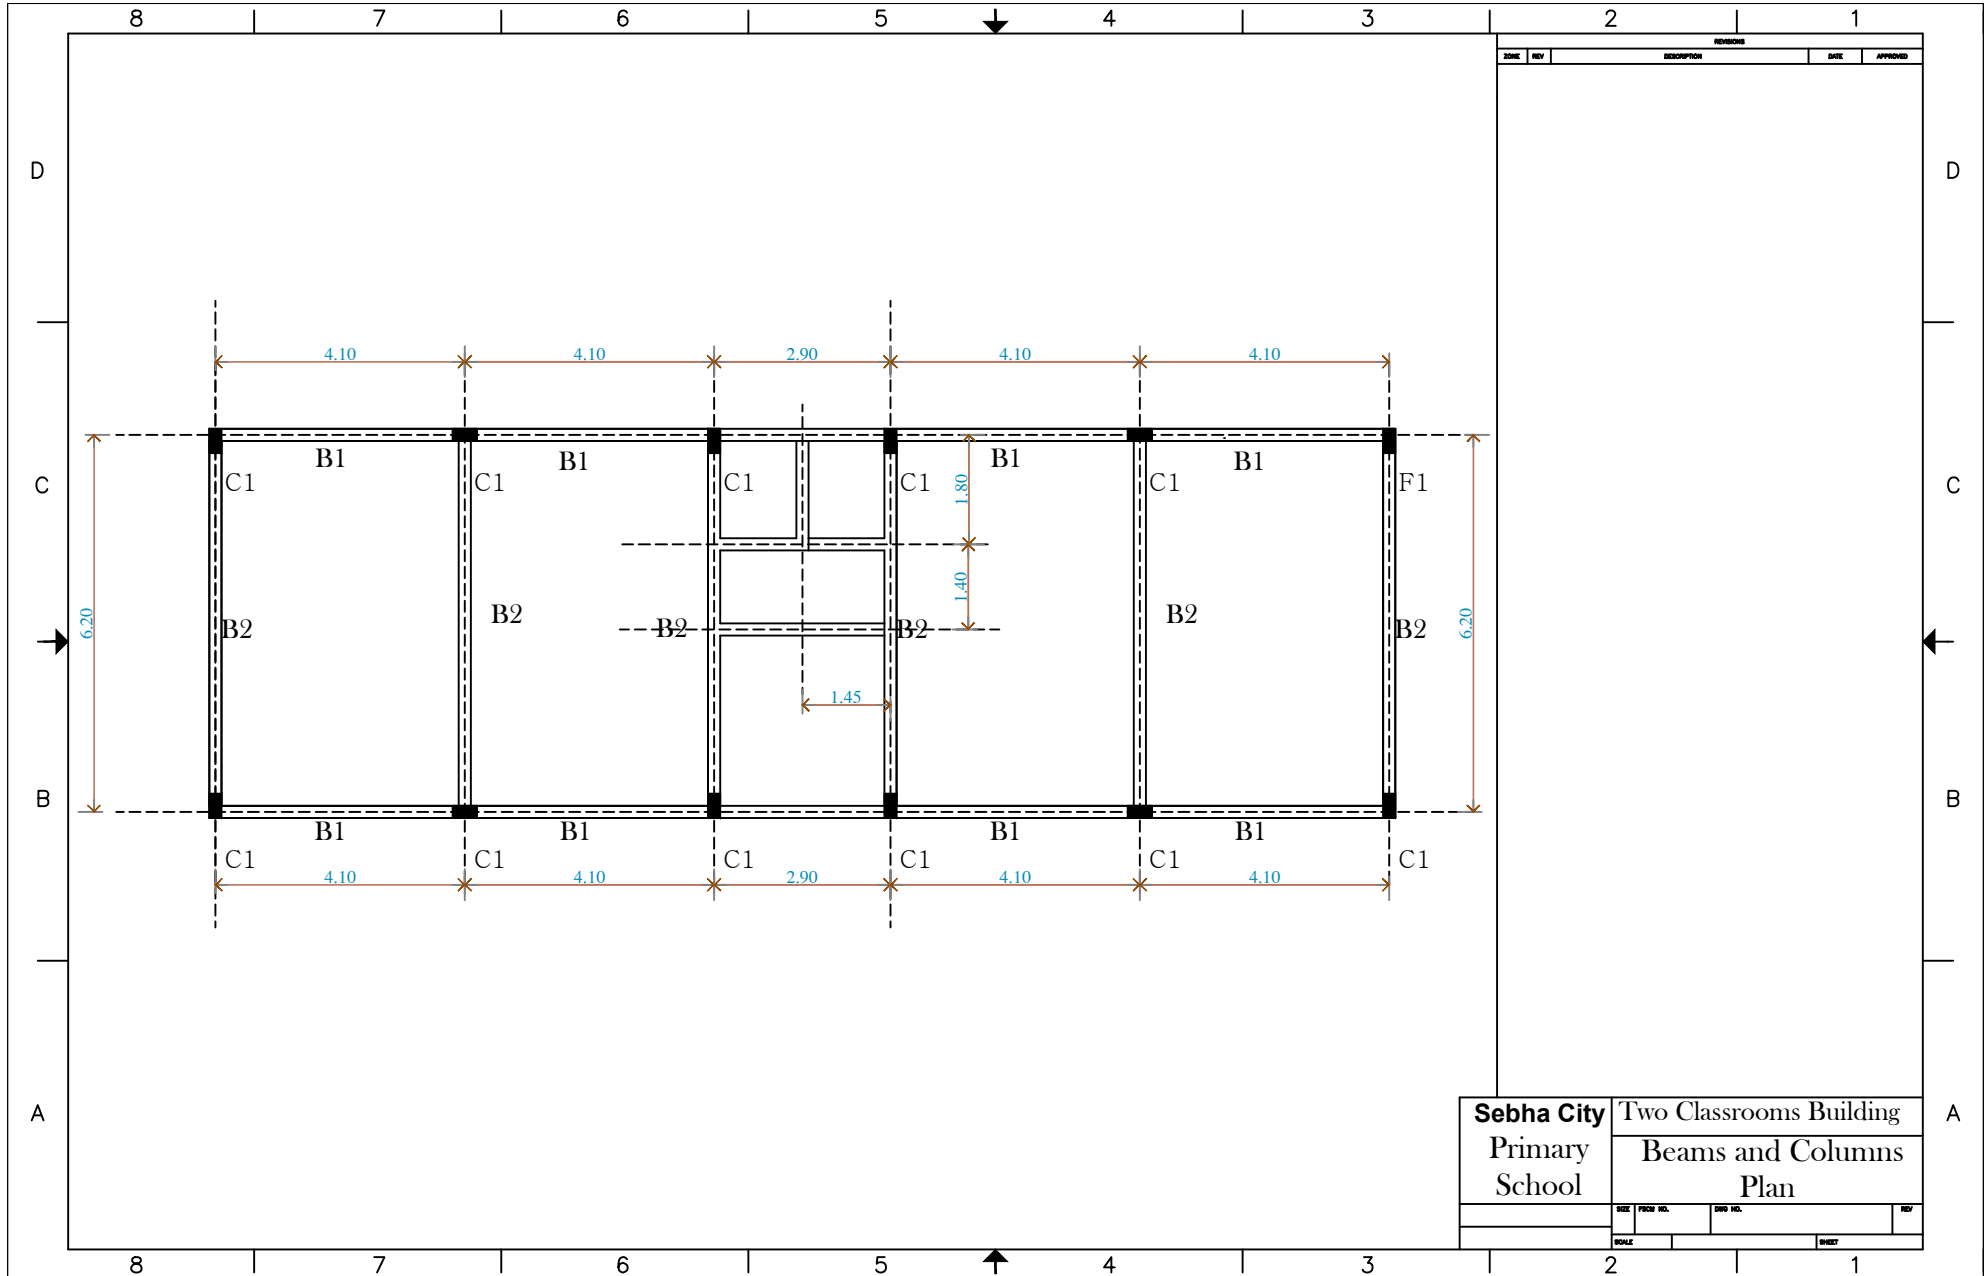


REVISIONS				
NO.	REV.	DESCRIPTION	DATE	APPROVED

Sebha City Primary School	Two Classrooms Building		
	Beams and Columns Plan		
SCALE	DATE	DRAWN	CHECKED

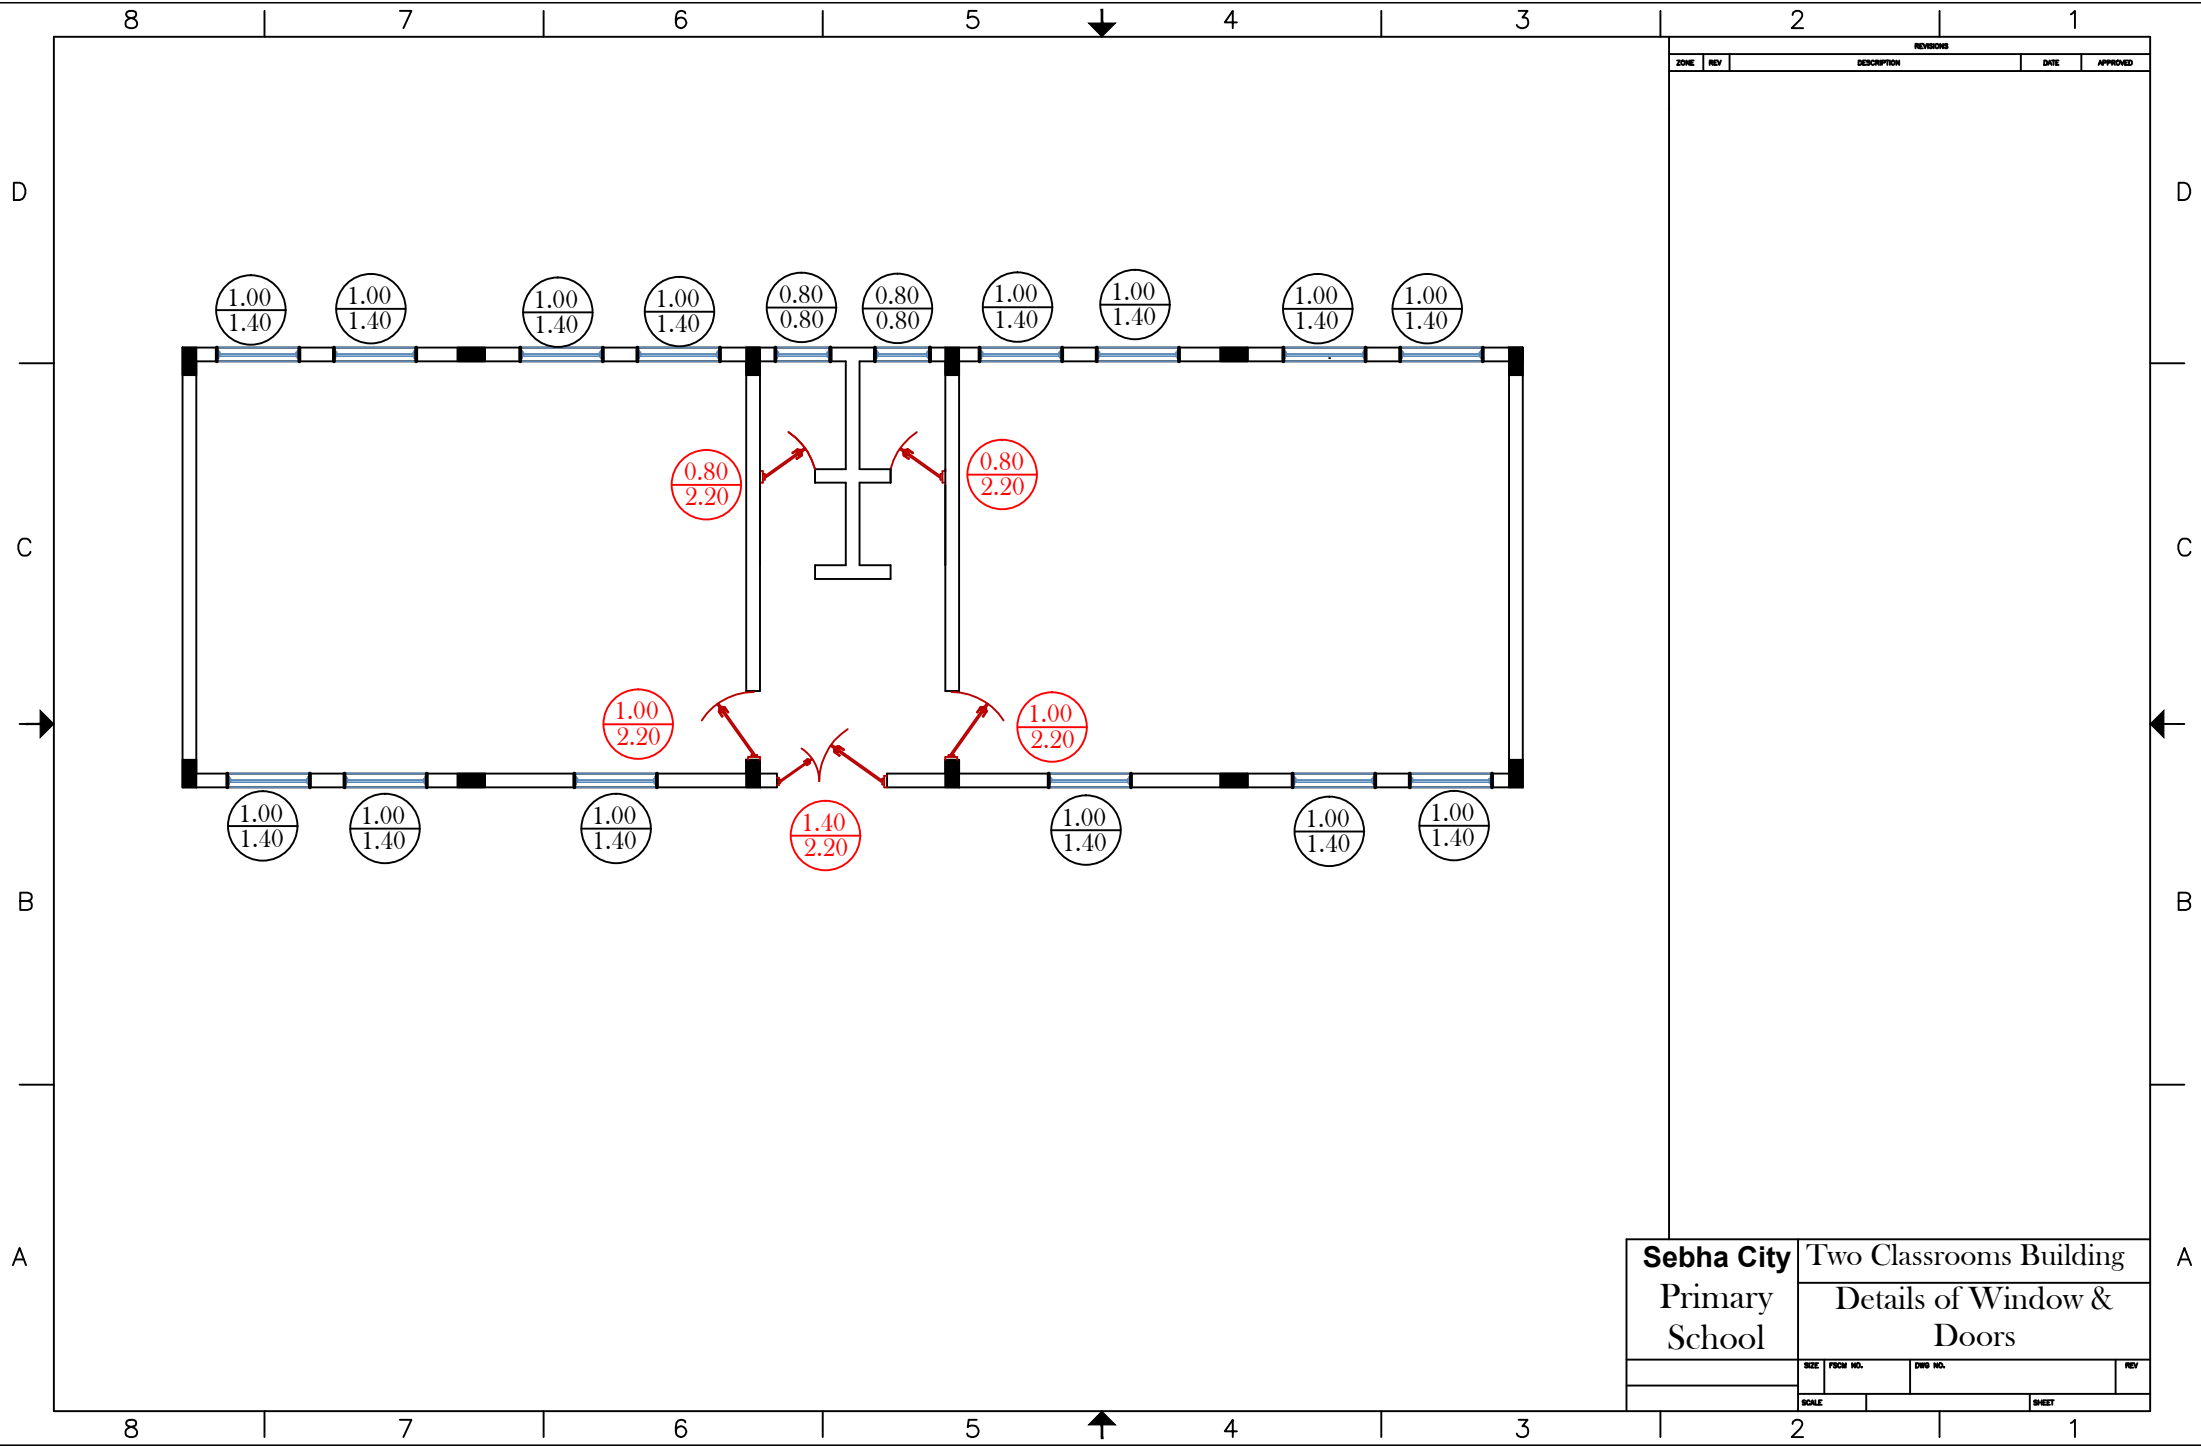


Sebha City Primary School	Two Classrooms Building		
	Details of Window & Doors		
SCALE	SIZE FROM NO.	DWG NO.	REV
	SHEET		

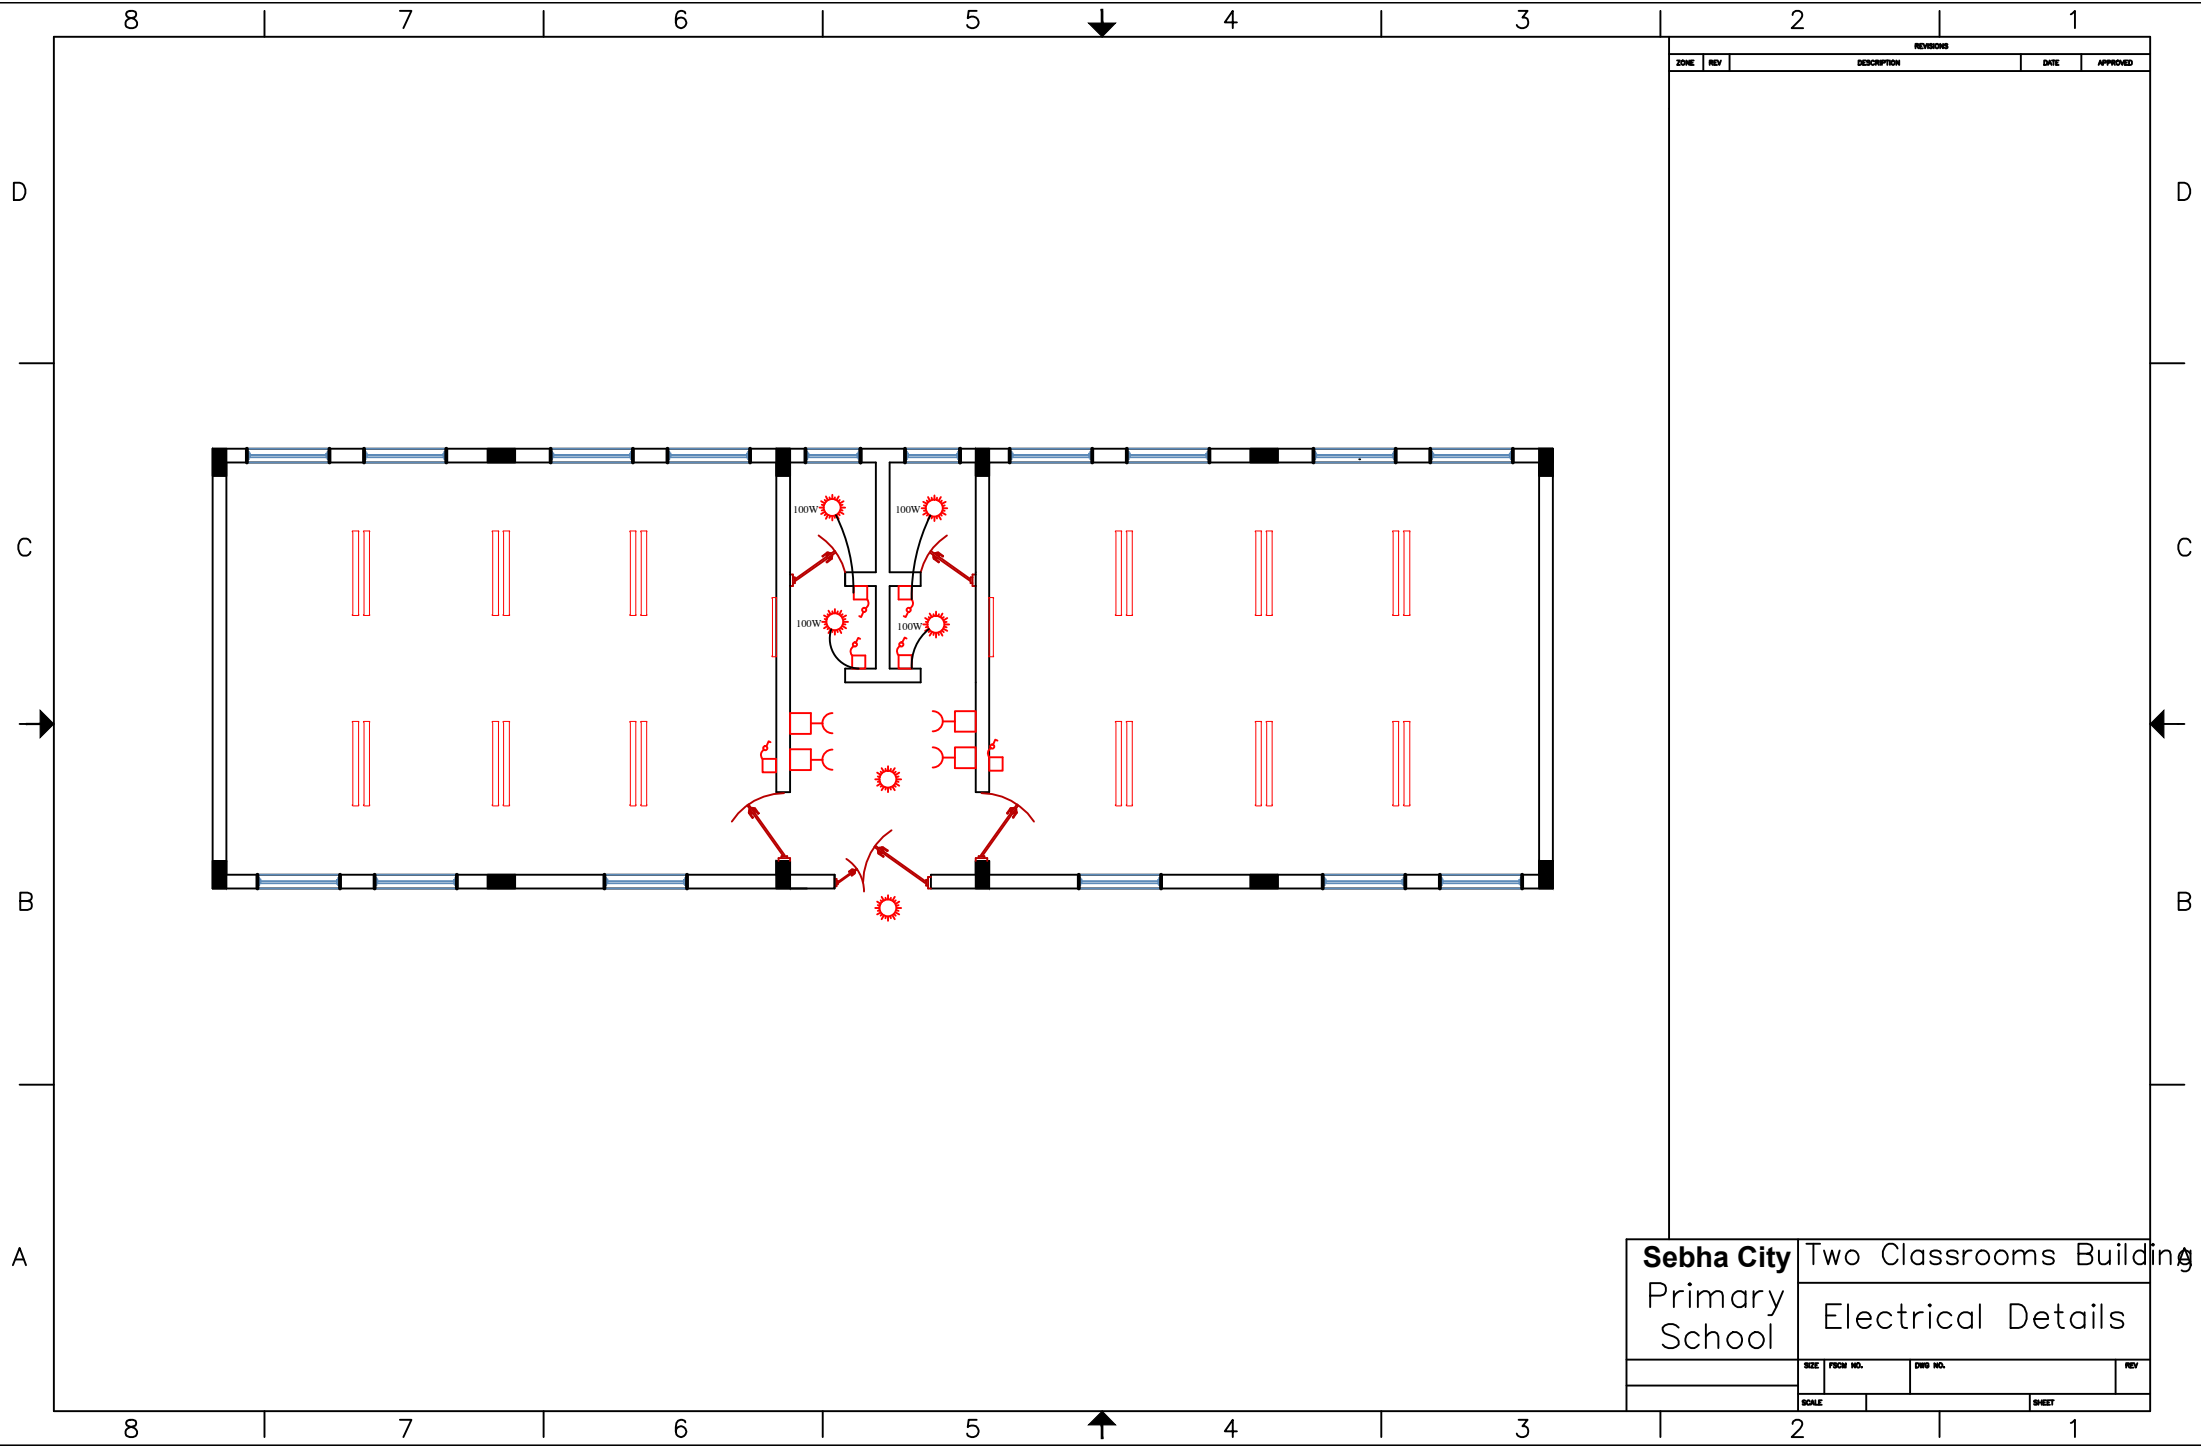

REVISIONS				
ZONE	REV	DESCRIPTION	DATE	APPROVED

Sebha City Primary School	Two Classrooms Building		
	Electrical Details		
	SIZE	FIG. NO.	DWG. NO.
	SCALE		SHEET

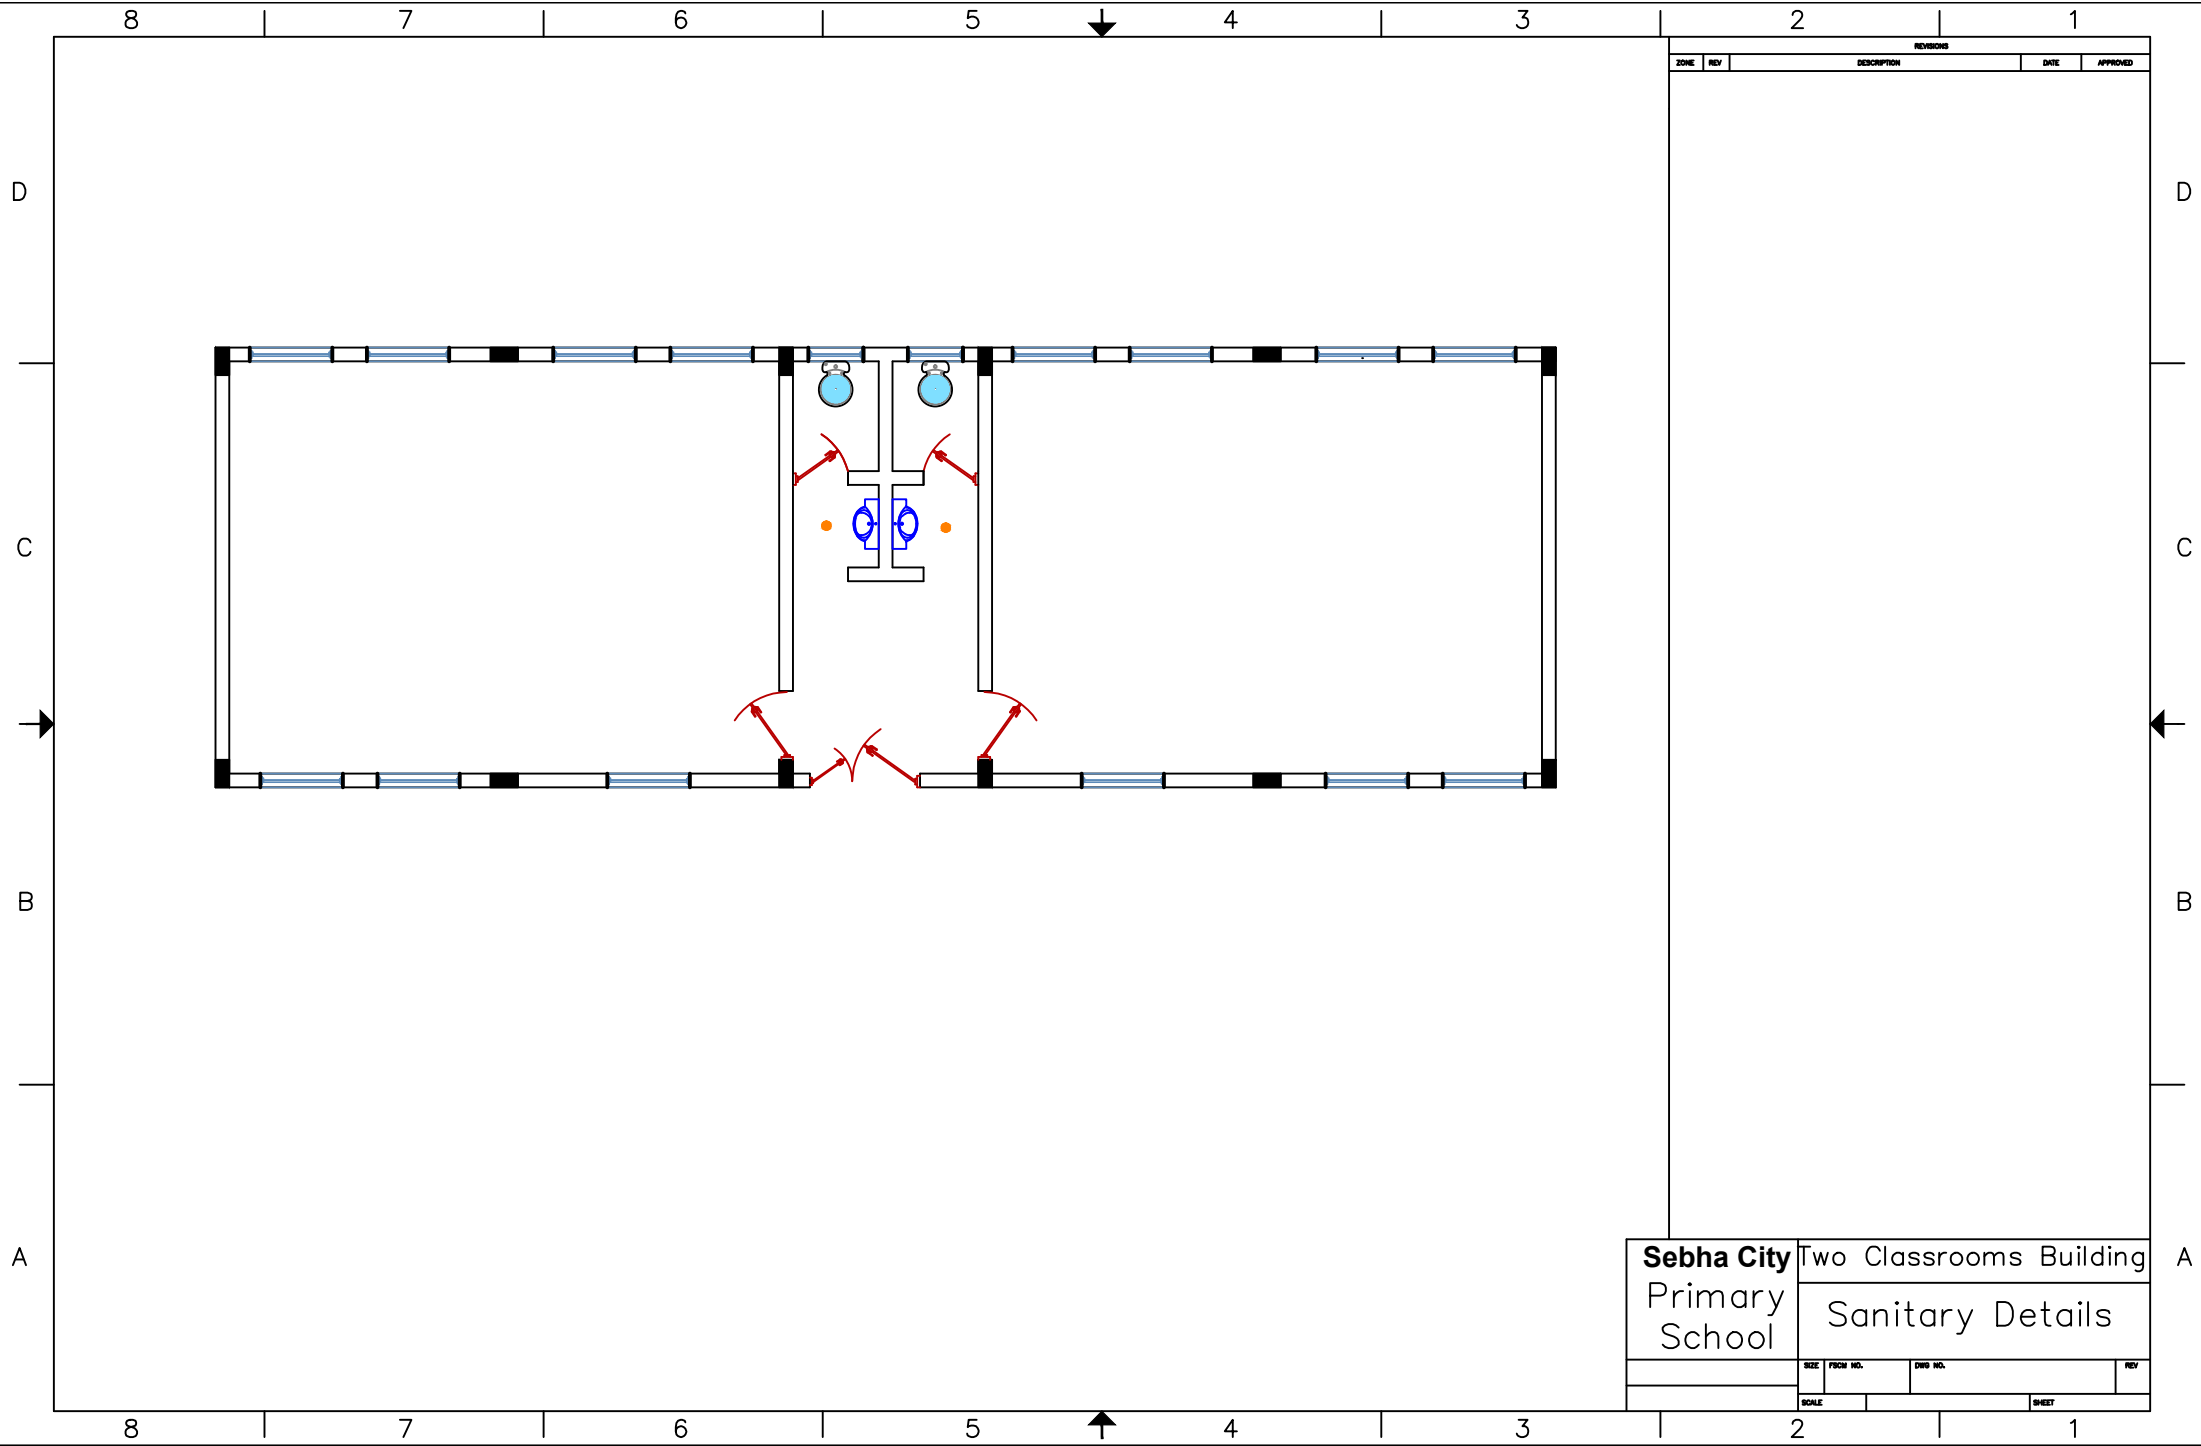

REVISIONS				
ZONE	REV	DESCRIPTION	DATE	APPROVED

Sebha City Primary School	Two Classrooms Building			
	Sanitary Details			
	SIZE	FROM NO.	DWG NO.	REV
	SCALE		SHEET	