



UNITED
NATIONS
INDONESIA



UNRC
INTERIOR SHOP DRAWING OFFICE

NOTE :

CLIENT

UNRC

PROJECT

UNRC OFFICE

DRAWING TITLE

DRAWING No.

REVISION

1920 INT-000

-

SCALE

CHECKED AA

DATE MAY 2019

DRAWN BP

NO	DRAWING CODE	DRAWING NAME	SCALE
INTERIOR			
1	INT-101	EXISTING PLAN	1 : 100
2	INT-101-1	DEMOLISH PLAN	1 : 100
3	INT-102	LAYOUT PLAN	1 : 100
4	INT-103	SECTIONS	1 : 100
5	INT-104	PARTITION PLAN	1 : 100
6	INT-105	WALL FINISH PLAN	1 : 100
7	INT-106	FLOOR FINISH PLAN	1 : 100
8	INT-107	DOOR PLAN	1 : 100
9	INT-108	SKIRTING PLAN	1 : 100
9	INT-109	EXISTING CEILING PLAN	1 : 100
9	INT-110	CEILING PLAN	1 : 100
DETAIL INTERIOR			
10	ID-101	GENERAL DETAIL (1)	NTS
11	ID-102	GENERAL DETAIL (2)	NTS
12	ID-103	GENERAL DETAIL (3)	NTS
13	ID-104	DOOR DETAIL	1 : 25
14	ID-105	BACKDROP, LOGO, GLASSBOARD DETAIL	1 : 20
15	ID-106	SANDBLAST DETAIL (1)	1 : 25
16	ID-107	SANDBLAST DETAIL (2)	1 : 25
MEP			
17	ME-101	POWER PLAN	1 : 100
18	ME-101-1	POWER PLAN GROUPING	1 : 100
19	ME-102	LIGHTING PLAN	1 : 100
20	ME-102-1	LIGHTING PLAN GROUPING	1 : 100
21	ME-103	SPRINKLER, SMOKE DETECTOR & SPEAKER PLAN	1 : 100
22	ME-104	AC PLAN	1 : 100
23	ME-105	REFLECTED CEILING PLAN	1 : 100
24	ME-106	WIRING DIAGRAM	1 : 100
FURNITURE			
25	FRN-101	STAFF'S WORKSTATION	1 : 25
26	FRN-102	MANAGER'S WORKSTATION	1 : 25
27	FRN-103	MANAGER'S WORKSTATION DIVIDER	1 : 25
28	FRN-104	DIRECTOR'S DESK	1 : 25
29	FRN-105	MEETING TABLE	1 : 25
30	FRN-106	DIRECTOR'S MEETING TABLE	1 : 25
31	FRN-107	CREDENZA	1 : 25
32	FRN-108	TWO-SIDED CABINET	1 : 25
33	FRN-109	MANAGER'S CABINET	1 : 25
34	FRN-110	FILING CABINET	1 : 25
35	FRN-111	PANTRY	1 : 25
36	FRN-112	BENCH	1 : 25
37	FRN-113	MEETING ROOM LAMP	1 : 25
38	FRN-114	WOOD PANELS	1 : 25
39	FRN-115	CORK BOARD	1 : 25

NOTE :

CLIENT

UNRC


PROJECT

UNRC OFFICE

DRAWING TITLE

TABLE OF CONTENTS

DRAWING No.	REVISION
1920 INT-001	-
SCALE	CHECKED AA
DATE MAY 2019	DRAWN BP

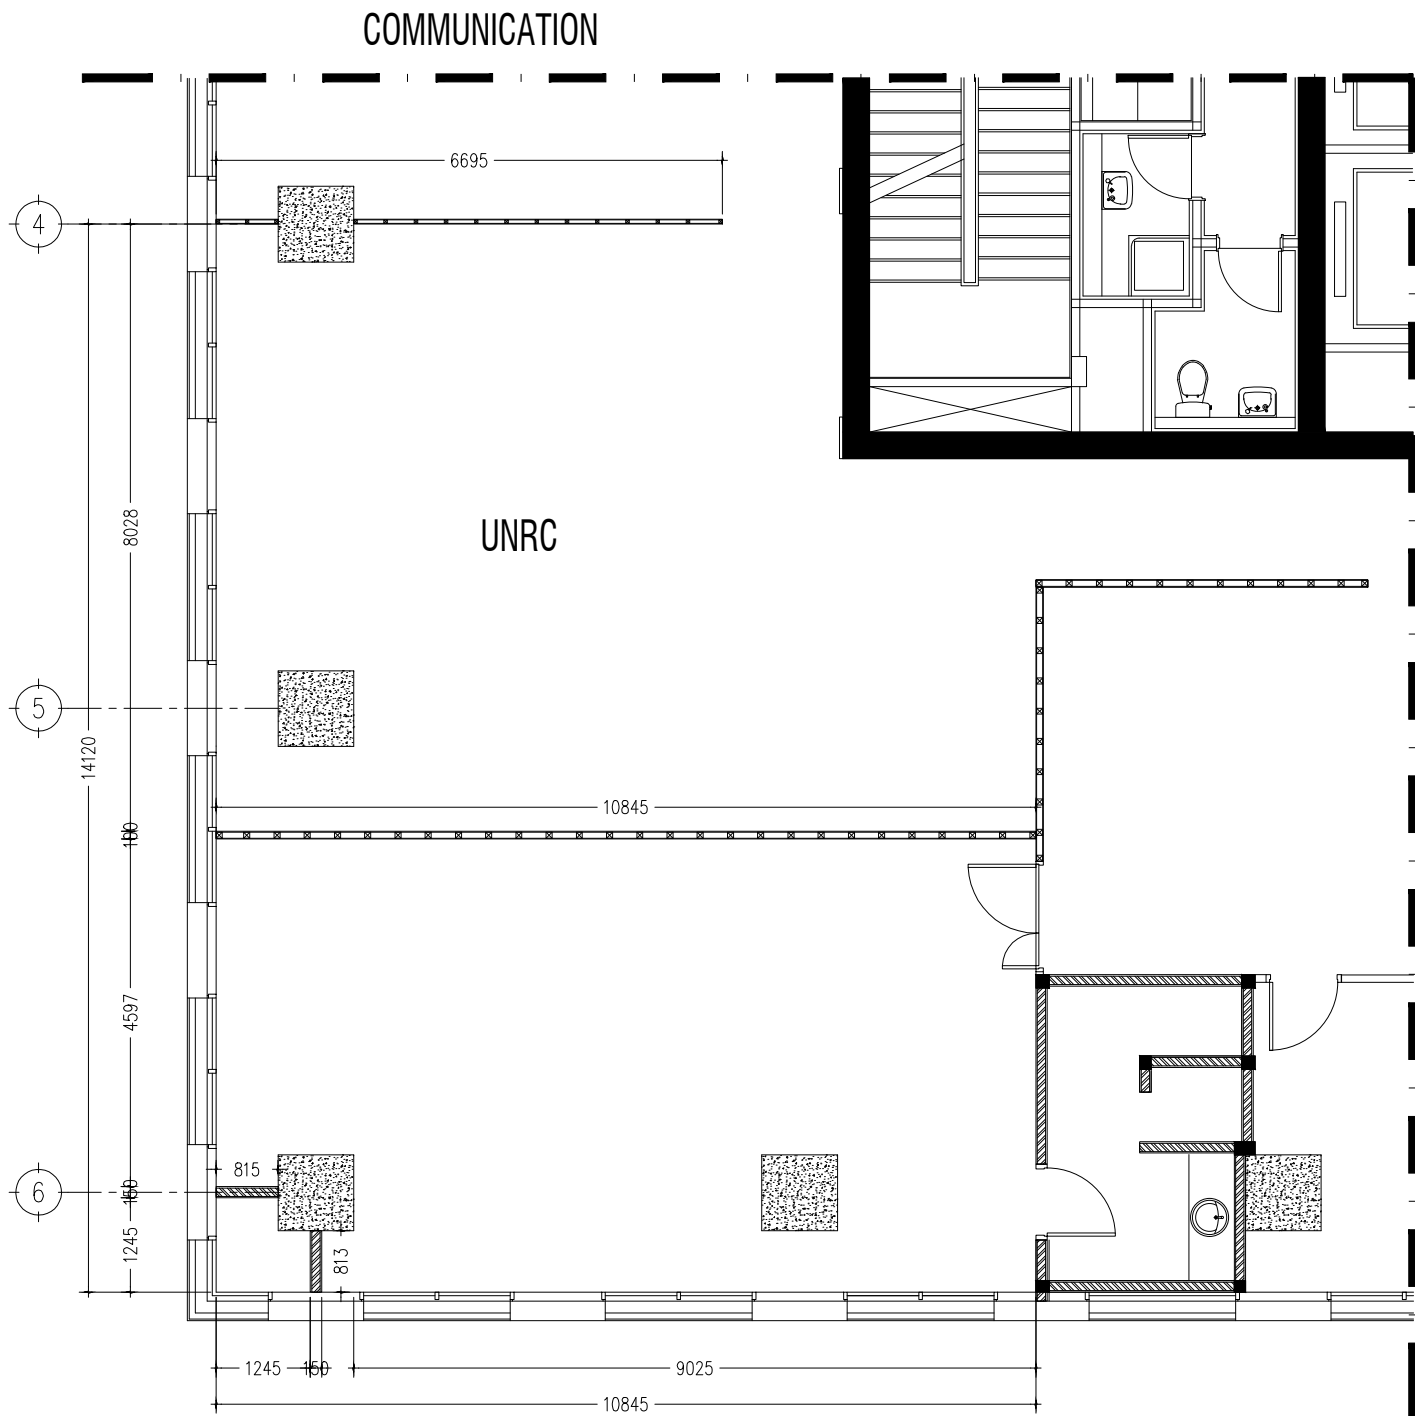

NOTE :

CLIENT

UNRC

PROJECT

UNRC OFFICE

DRAWING TITLE

EXISTING PLAN

DRAWING No.

REVISION

1920 INT-101


-

SCALE 1:100

CHECKED AA

DATE MAY 2019


DRAWN BP

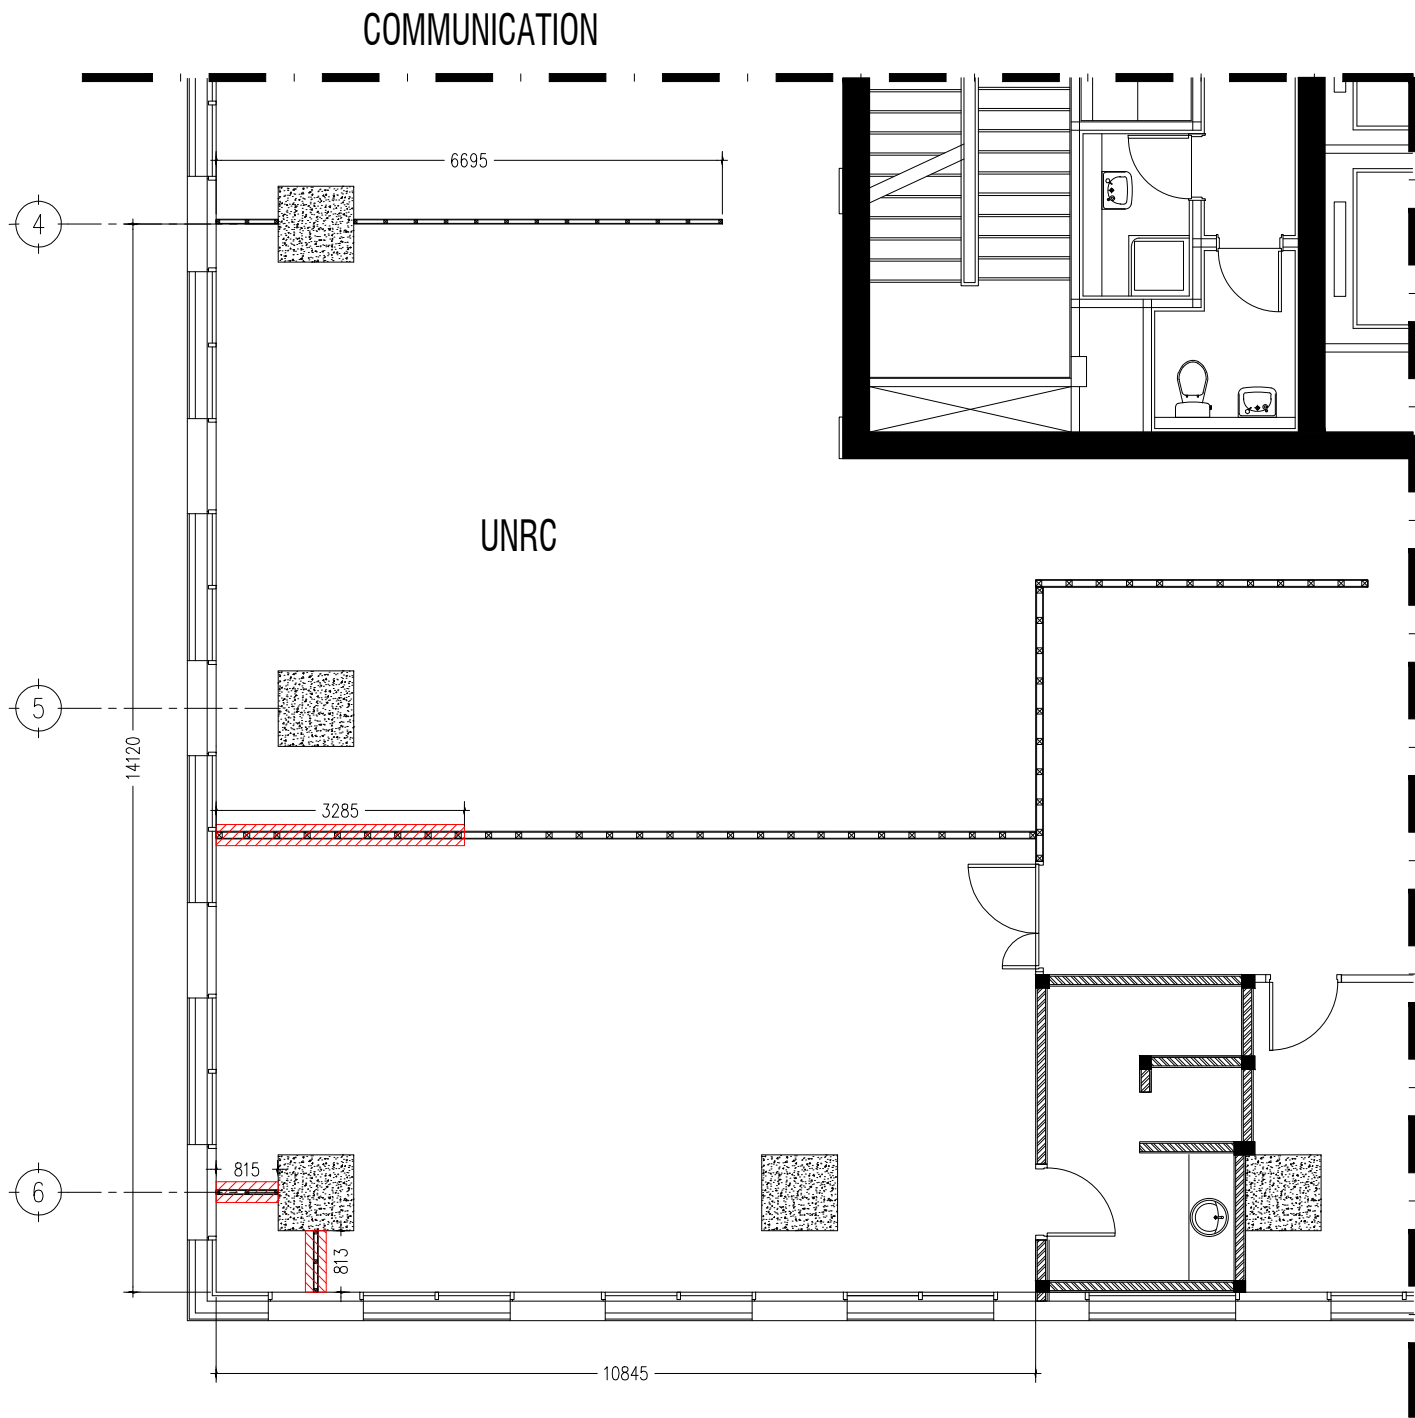

NOTE :


DE DEMOLISHED

CLIENT	
UNRC	
PROJECT	
UNRC OFFICE	
DRAWING TITLE	
DEMOLITION PLAN	
DRAWING No.	REVISION
1920 INT-102	-
SCALE 1:100	CHECKED AA
DATE MAY 2019	DRAWN BP

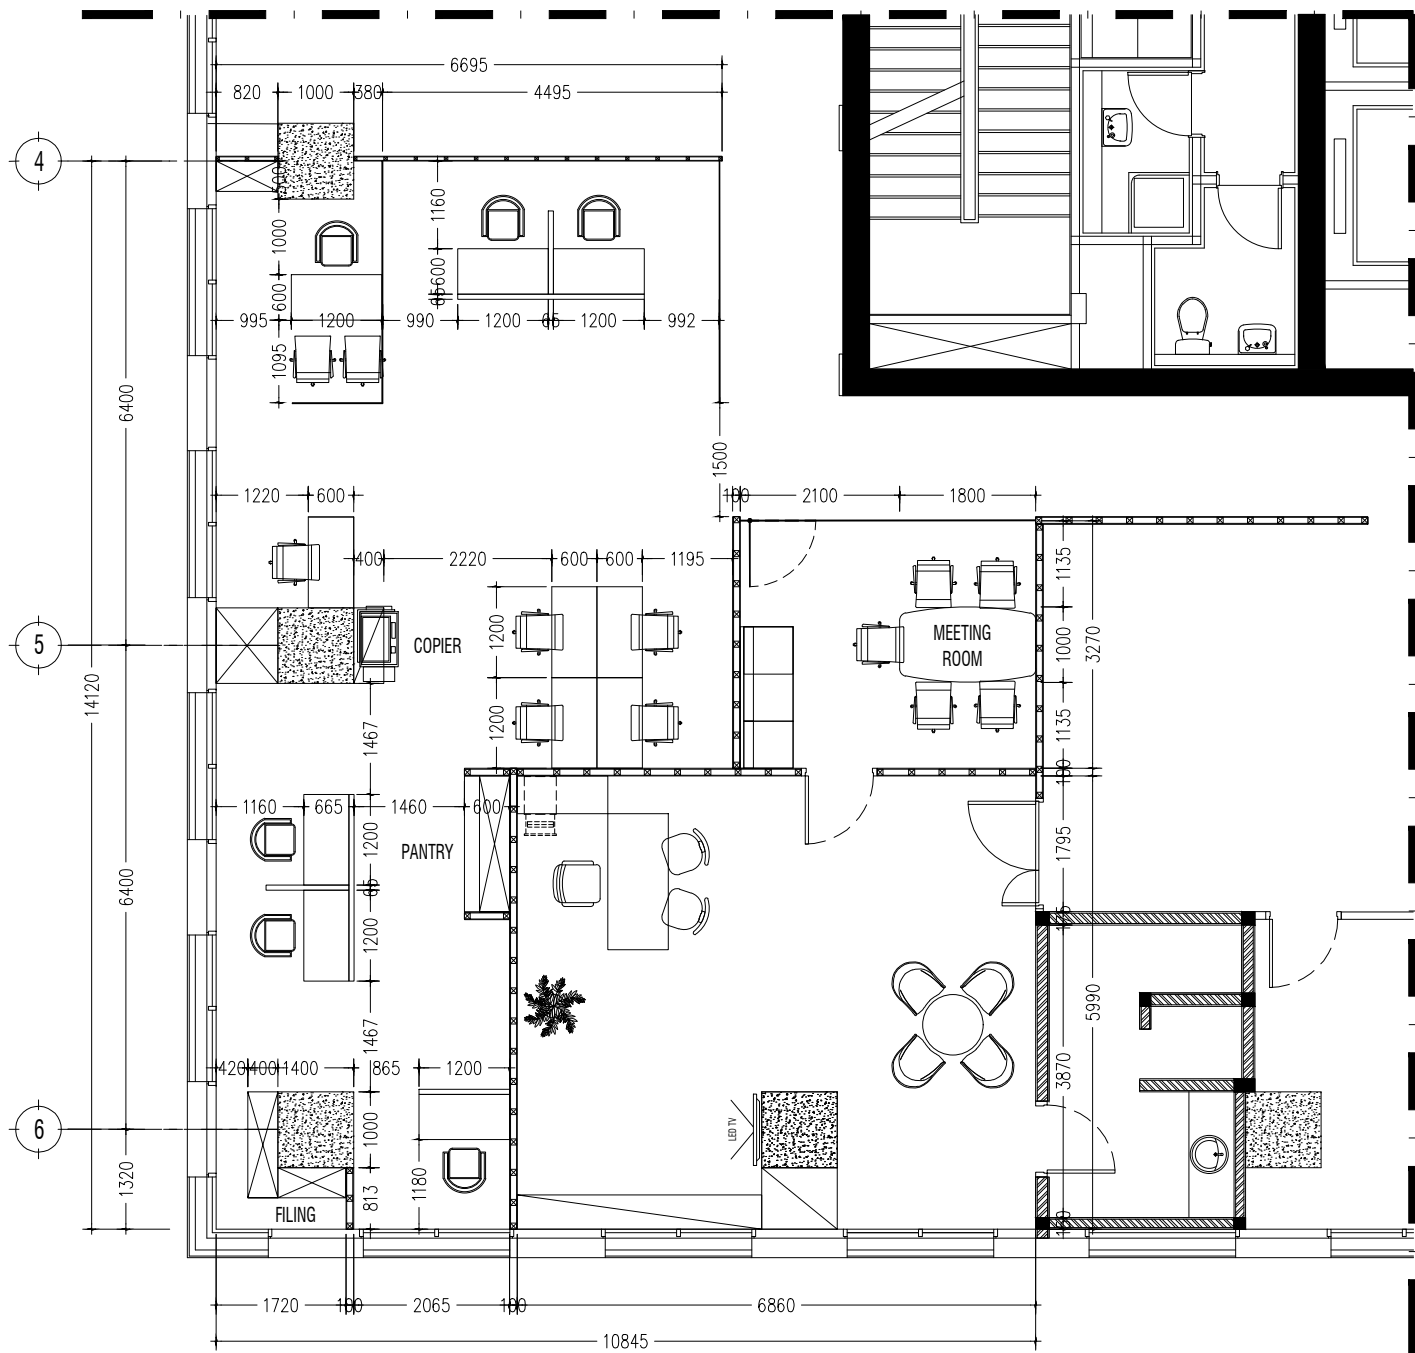


NOTE :

CLIENT	
UNRC	
PROJECT	
UNRC OFFICE	
DRAWING TITLE	
LAYOUT PLAN	
DRAWING No.	REVISION
1920 INT-103	-
SCALE 1:100	CHECKED AA
DATE MAY 2019	DRAWN BP

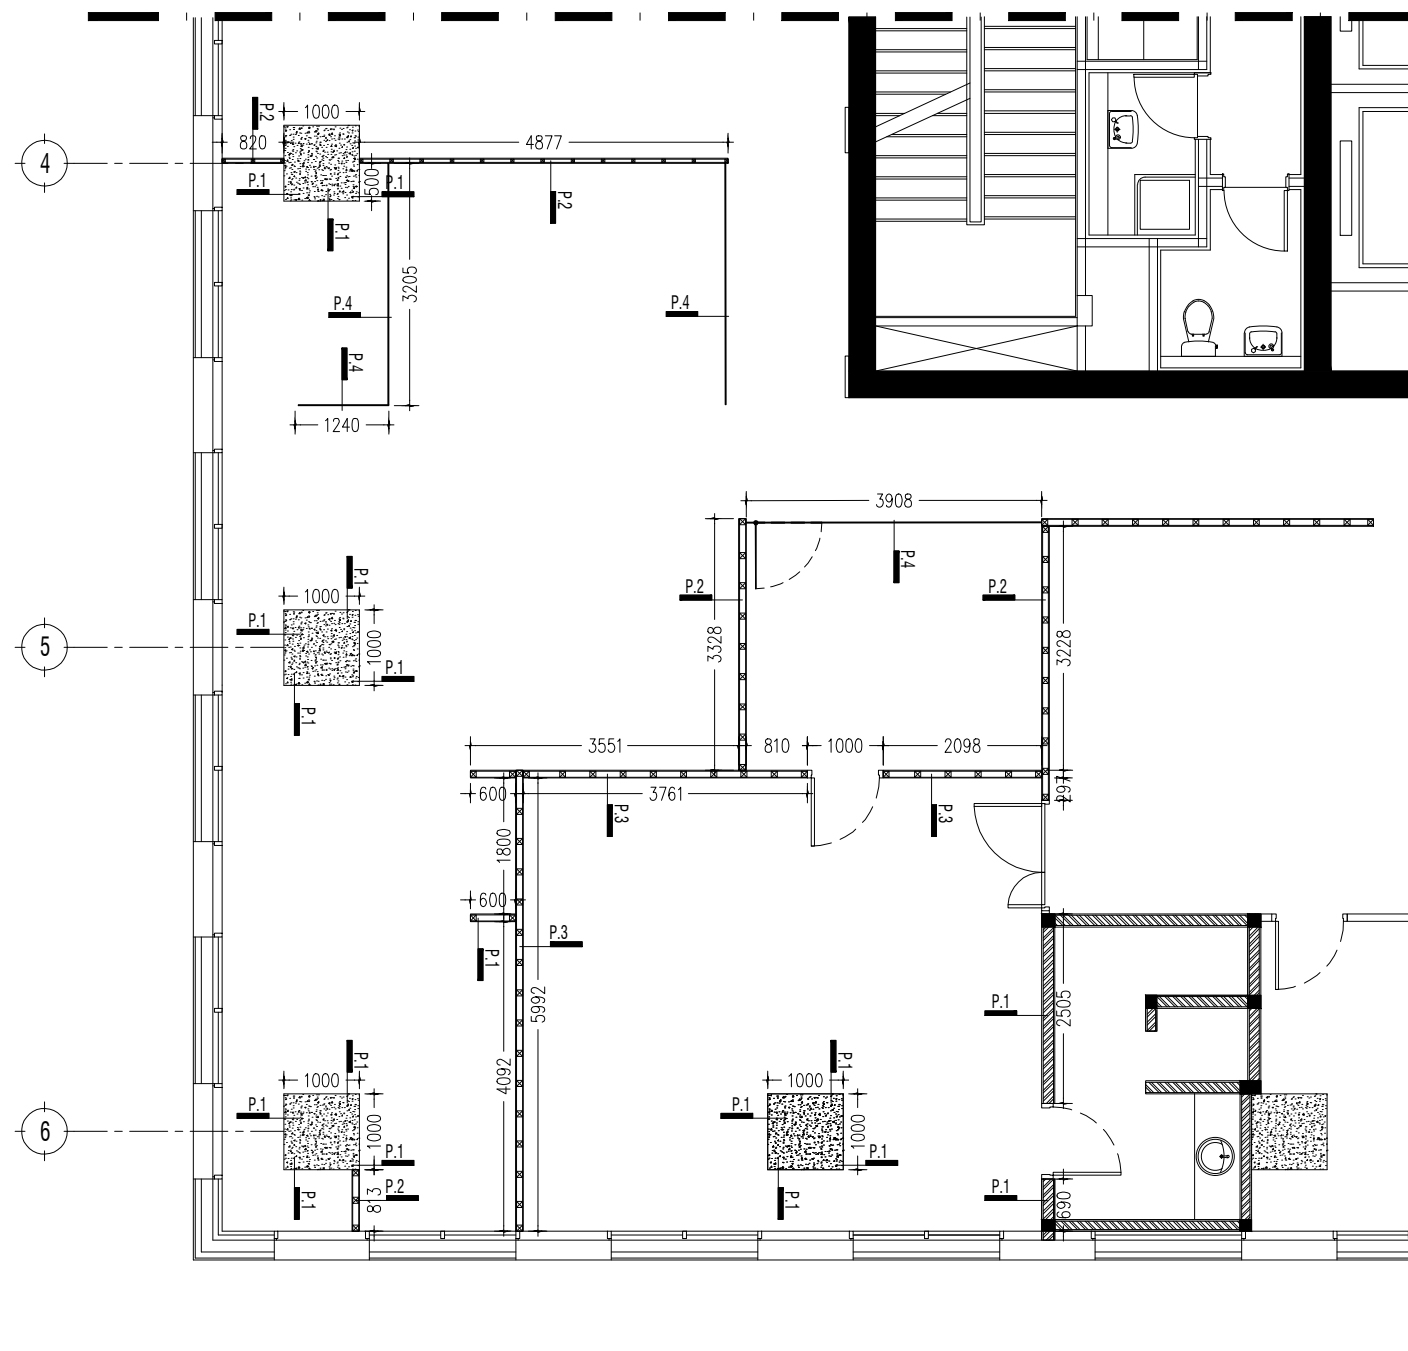

PARTITION	
<u>P.1</u>	ONE SIDE GYPSUM
<u>P.2</u>	TWO SIDE GYPSUM
<u>P.3</u>	TWO SIDE GYPSUM W/ INSULATION
<u>P.4</u>	GLASS PARTITION


CLIENT	
UNRC	
PROJECT	
UNRC OFFICE	
DRAWING TITLE	
PARTITION PLAN	
DRAWING No.	REVISION
1920 INT-104	-
SCALE 1:100	CHECKED AA
DATE MAY 2019	DRAWN BP

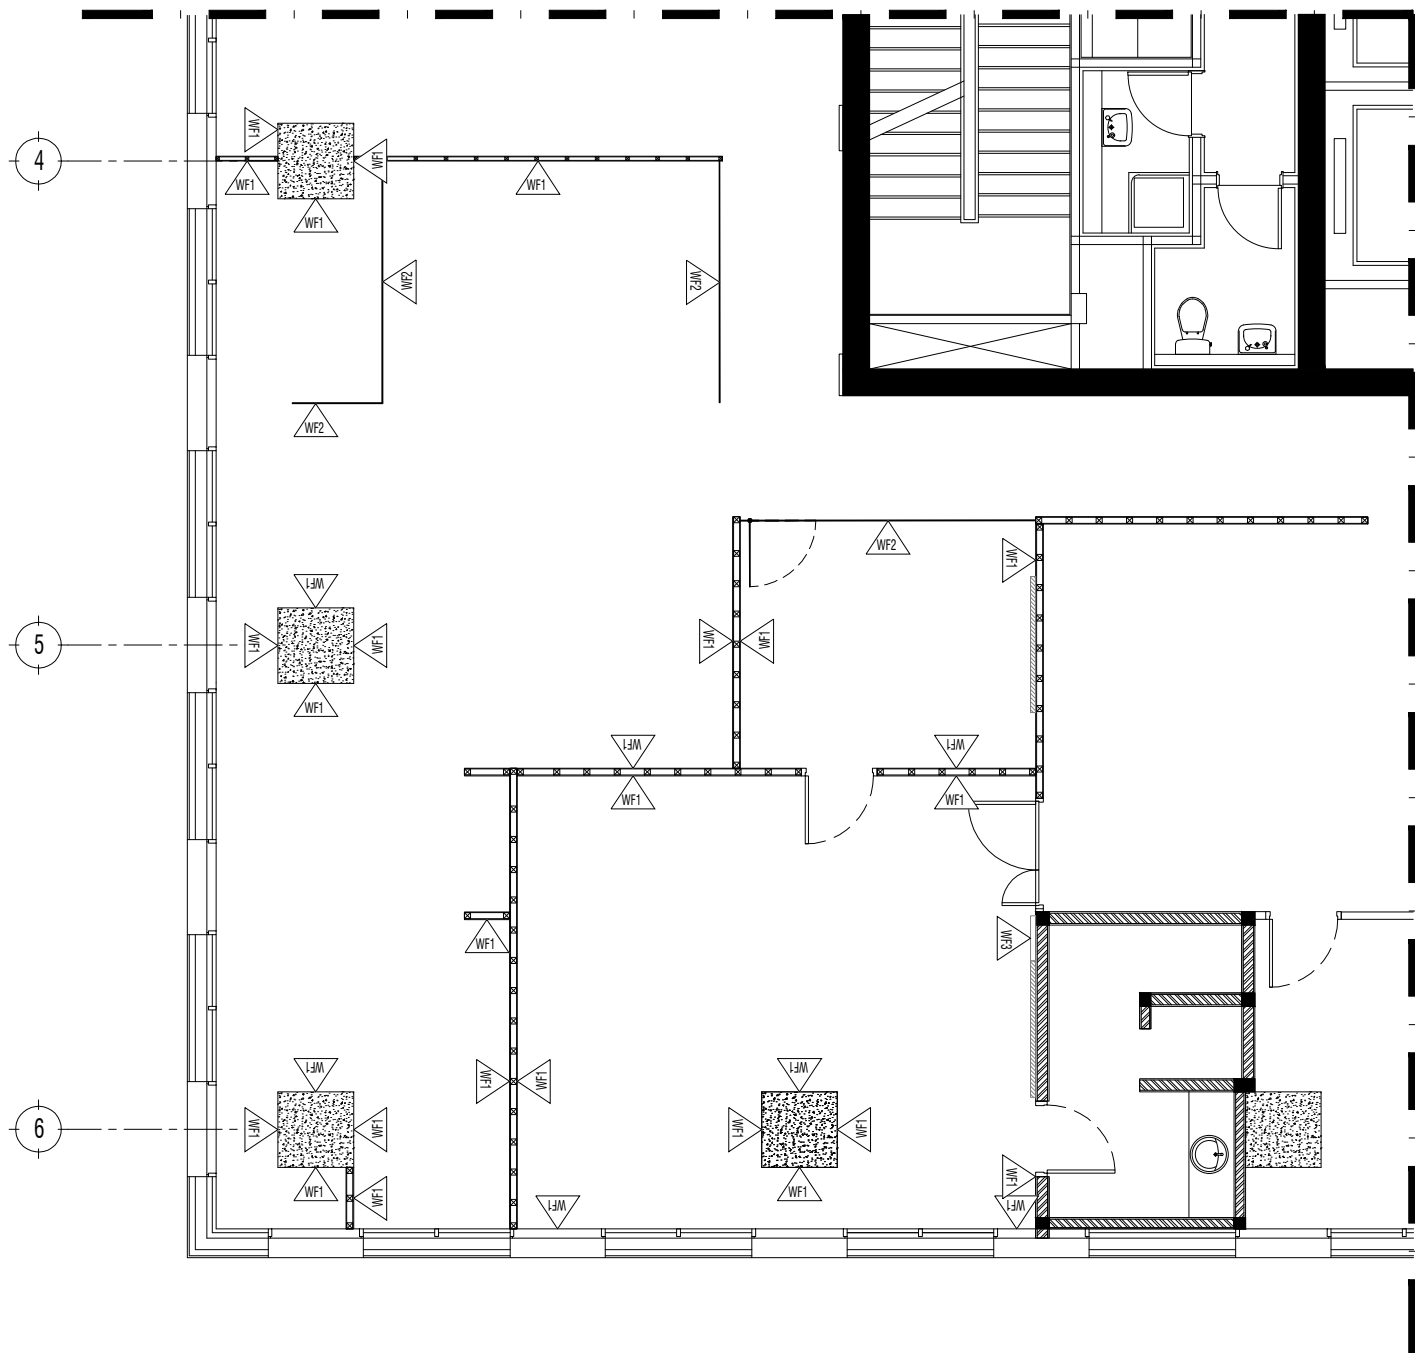

NOTE :


WALL FINISH	
	WALLPAPER
	SANDBLAST
	LOGO
	GLASS STONE

CLIENT	
UNRC	
PROJECT	
UNRC OFFICE	
DRAWING TITLE	
WALL FINISH PLAN	
DRAWING No.	REVISION
1920 INT-105	-
SCALE 1:100	CHECKED AA
DATE MAY 2019	DRAWN BP

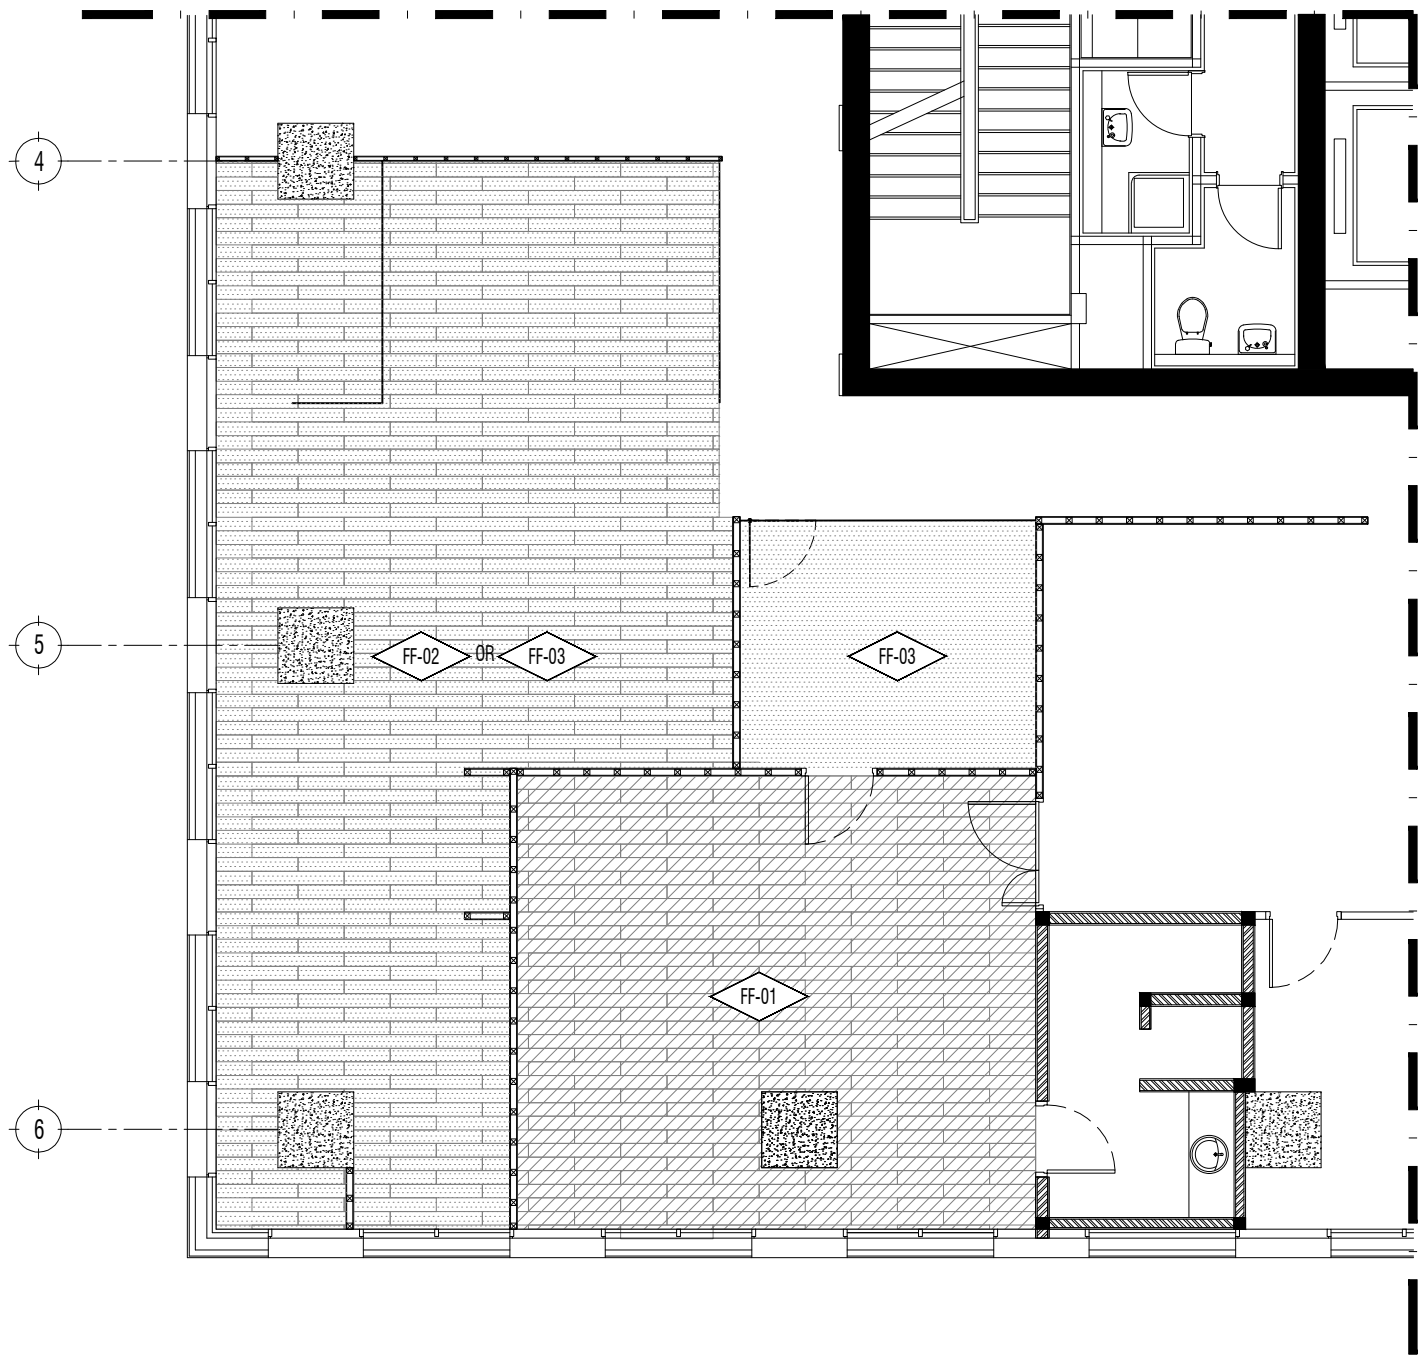

FLOOR FINISH	
FF-01	PARQUET FLOORING (EXISTING)
FF-02	SPC FLOORING (OPTIONAL)
FF-03	PARQUET FLOORING (OPTIONAL)

CLIENT	
UNRC	
PROJECT	
UNRC OFFICE	
DRAWING TITLE	
FLOOR FINISH PLAN	
DRAWING No.	REVISION
1920 INT-106	-
SCALE 1:100	CHECKED AA
DATE MAY 2019	DRAWN BP

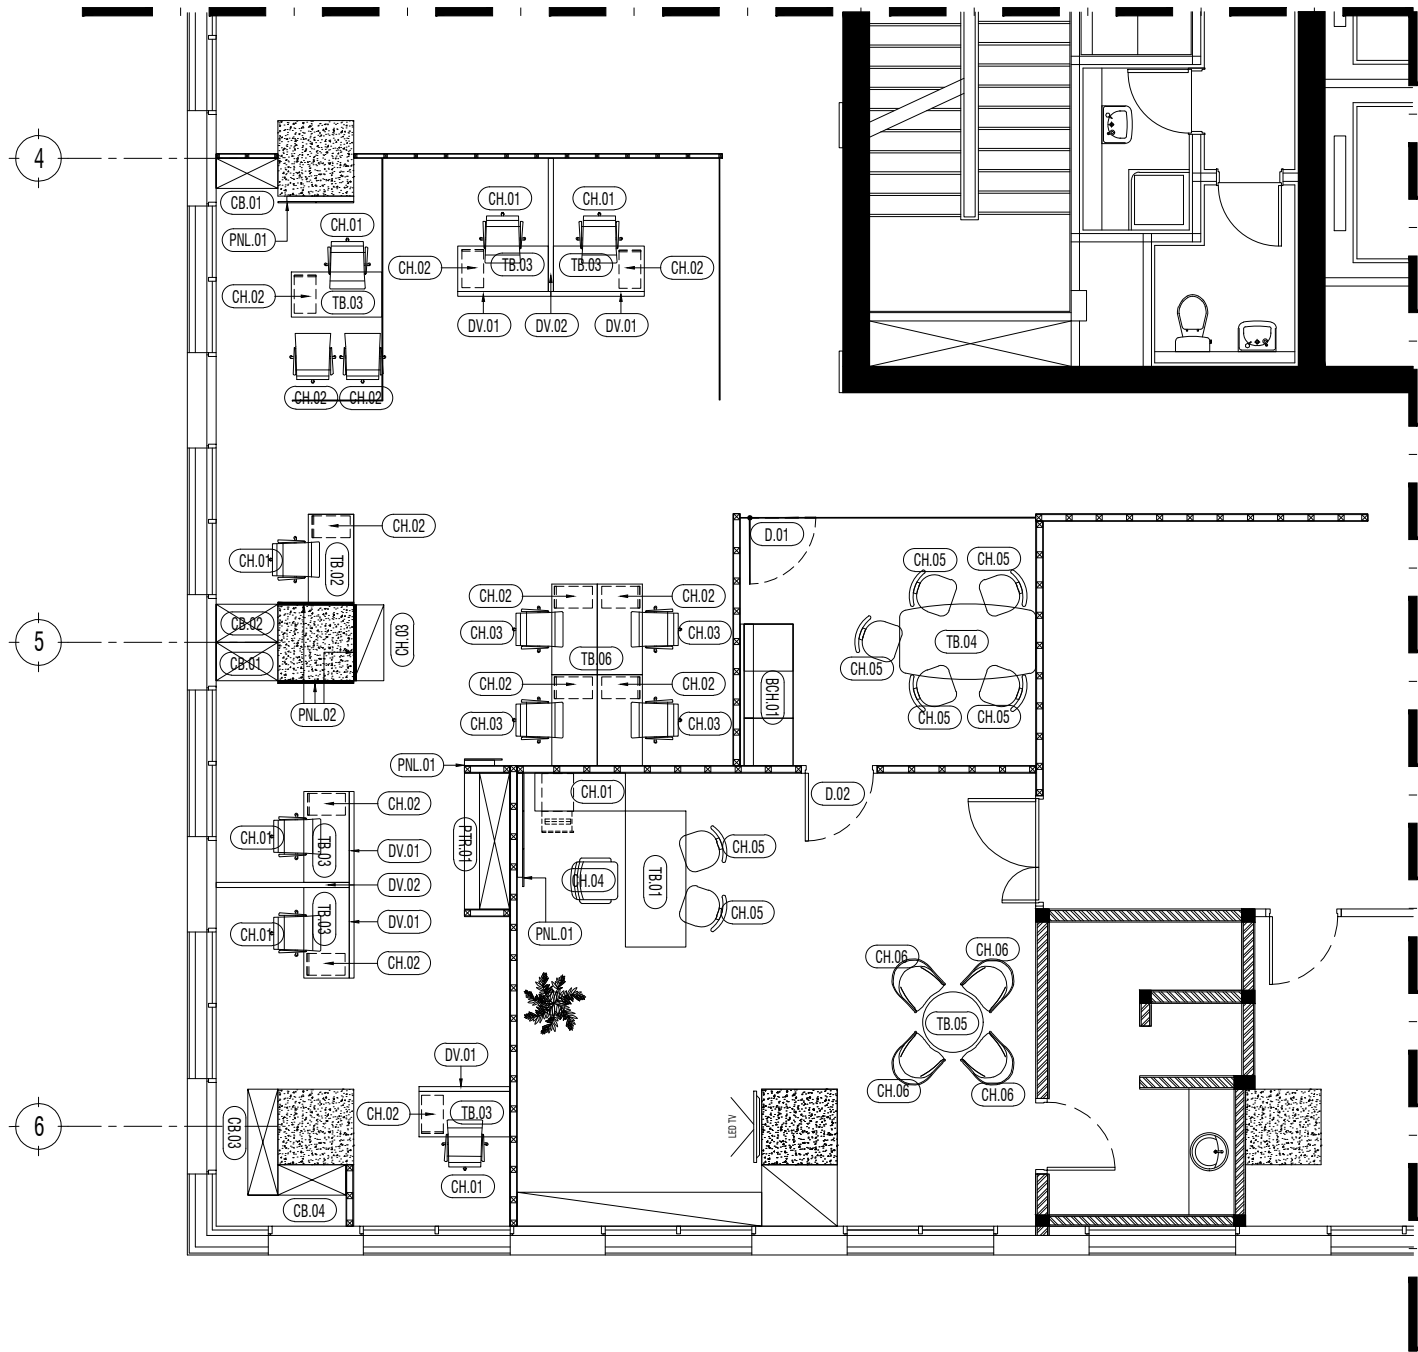


NOTE :

FURNITURE	
TB.01	DIRECTOR WORKSTATION (W:2300)
TB.02	STAFF WORKSTATION (W:1200)
TB.03	MANAGER WORKSTATION (W:1400)
TB.04	MEETING TABLE
TB.05	DISCUSSION TABLE
TB.06	4 STAFF WORKSTATIONS
CR.01	DIRECTOR TABLE CREDENZA
CR.02	WORKSTATION CREDENZA
CR.03	COPY CREDENZA
CB.01	CABINET
CB.02	OPEN CABINET
CB.03	FILLING CABINET
CB.04	FILLING CABINET
PTR.01	PANTRY
BCH.01	BENCH
DV.01	DIVIDER L:1300
DV.02	DIVIDER L:1700
PNL.01	WALL PANEL
PNL.02	CORK PANEL

DOORS	
D.01	SINGLE GLASS DOOR
D.02	STEEL DOOR W/ SOUNDPROOFING


CLIENT	
UNRC	
PROJECT	
UNRC OFFICE	
DRAWING TITLE	
DOOR AND FURNITURE PLAN	
DRAWING No.	REVISION
1920 INT-107	-
SCALE 1:100	CHECKED AA
DATE MAY 2019	DRAWN BP

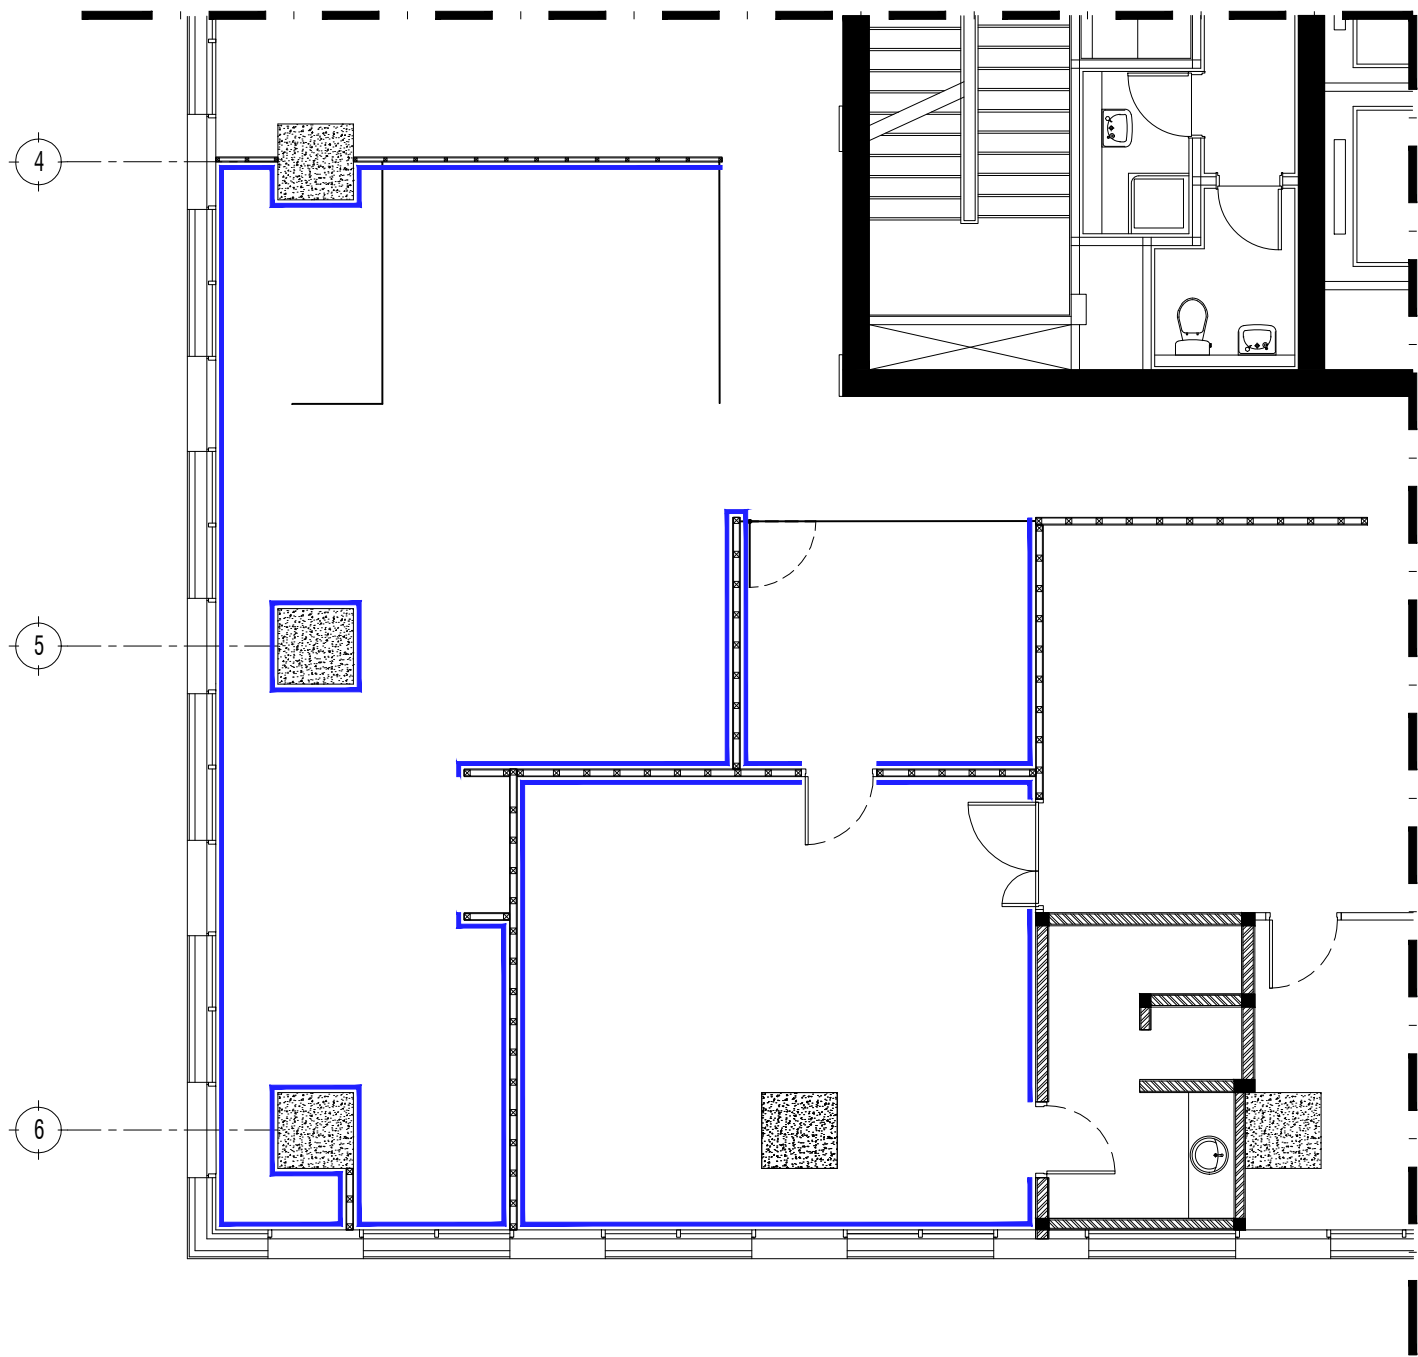

NOTE :


SKIRTING PLAN	
	SKIRTING

CLIENT	
UNRC	
PROJECT	
UNRC OFFICE	
DRAWING TITLE	
SKIRTING PLAN	
DRAWING No.	REVISION
1920 INT-108	-
SCALE 1:100	CHECKED AA
DATE MAY 2019	DRAWN BP

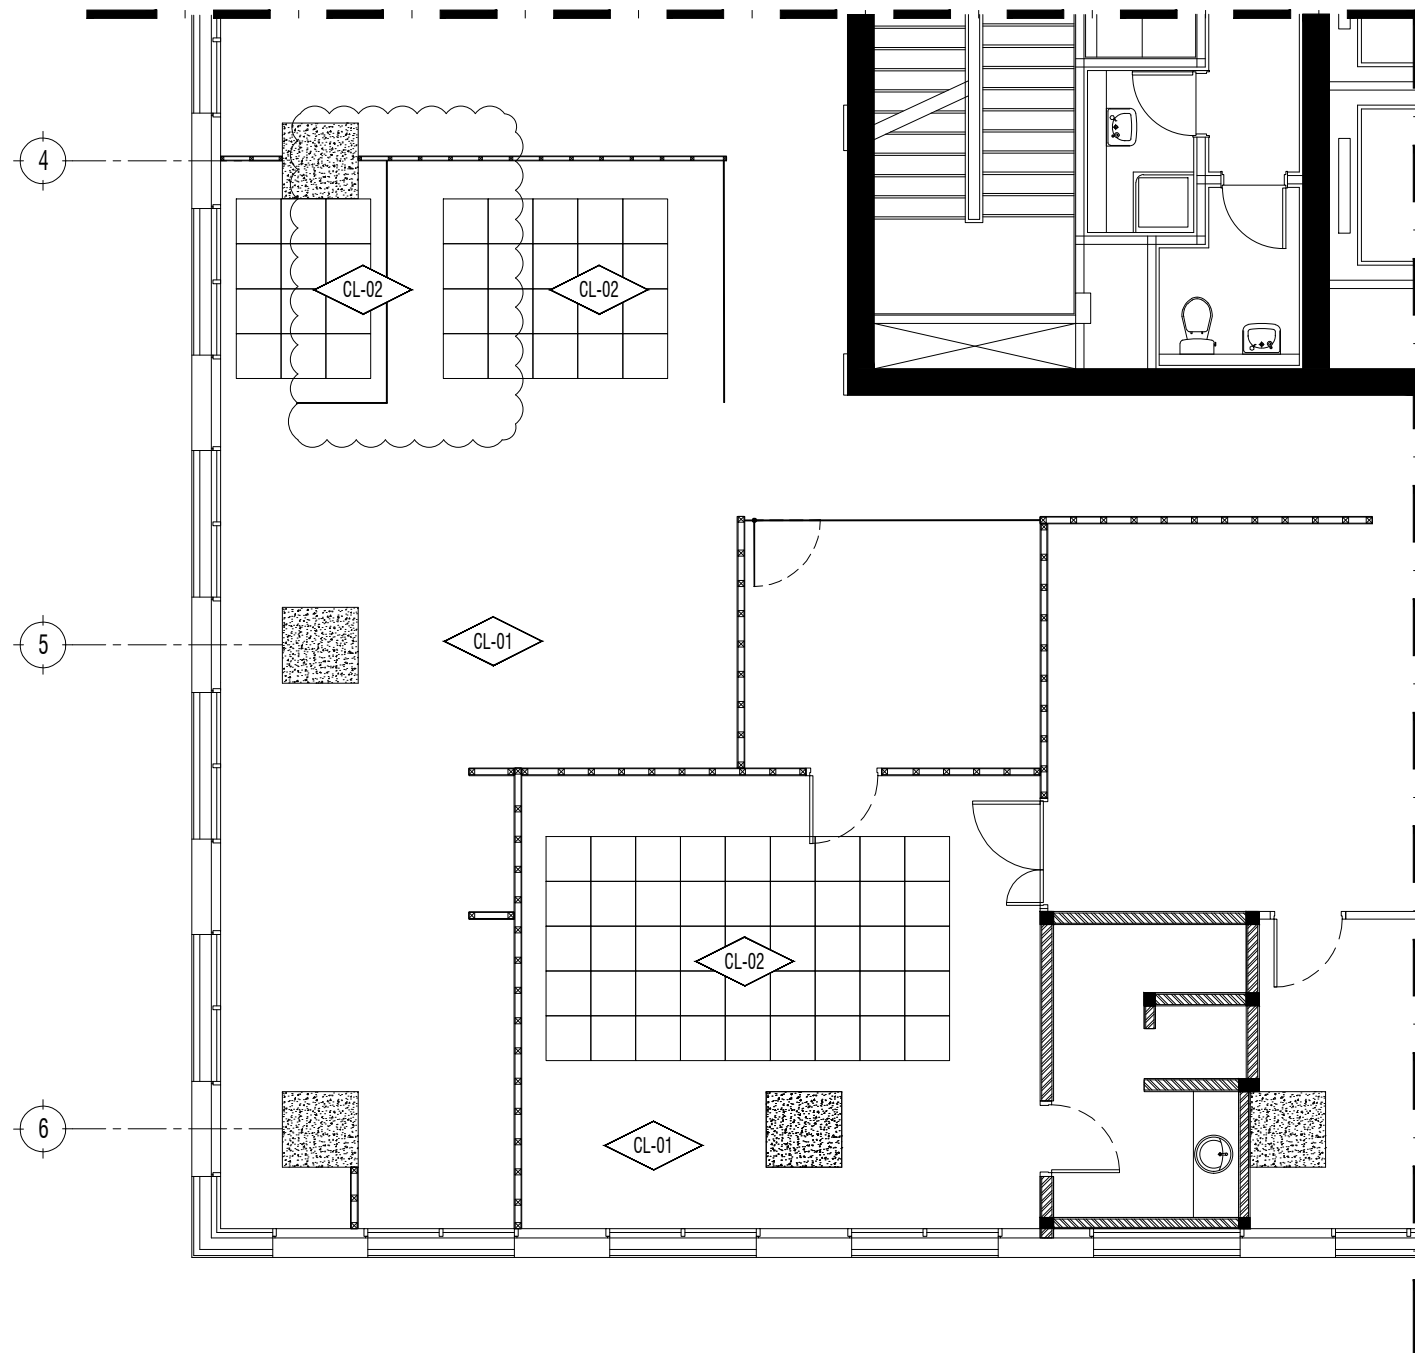


NOTE :	
CEILING	
CL-01	GYPSUM CEILING
CL-02	TILE CEILING

CLIENT	
UNRC	
PROJECT	
UNRC OFFICE	
DRAWING TITLE	
CEILING PLAN	
DRAWING No.	REVISION
1920 INT-110	-
SCALE 1:100	CHECKED AA
DATE MAY 2019	DRAWN BP

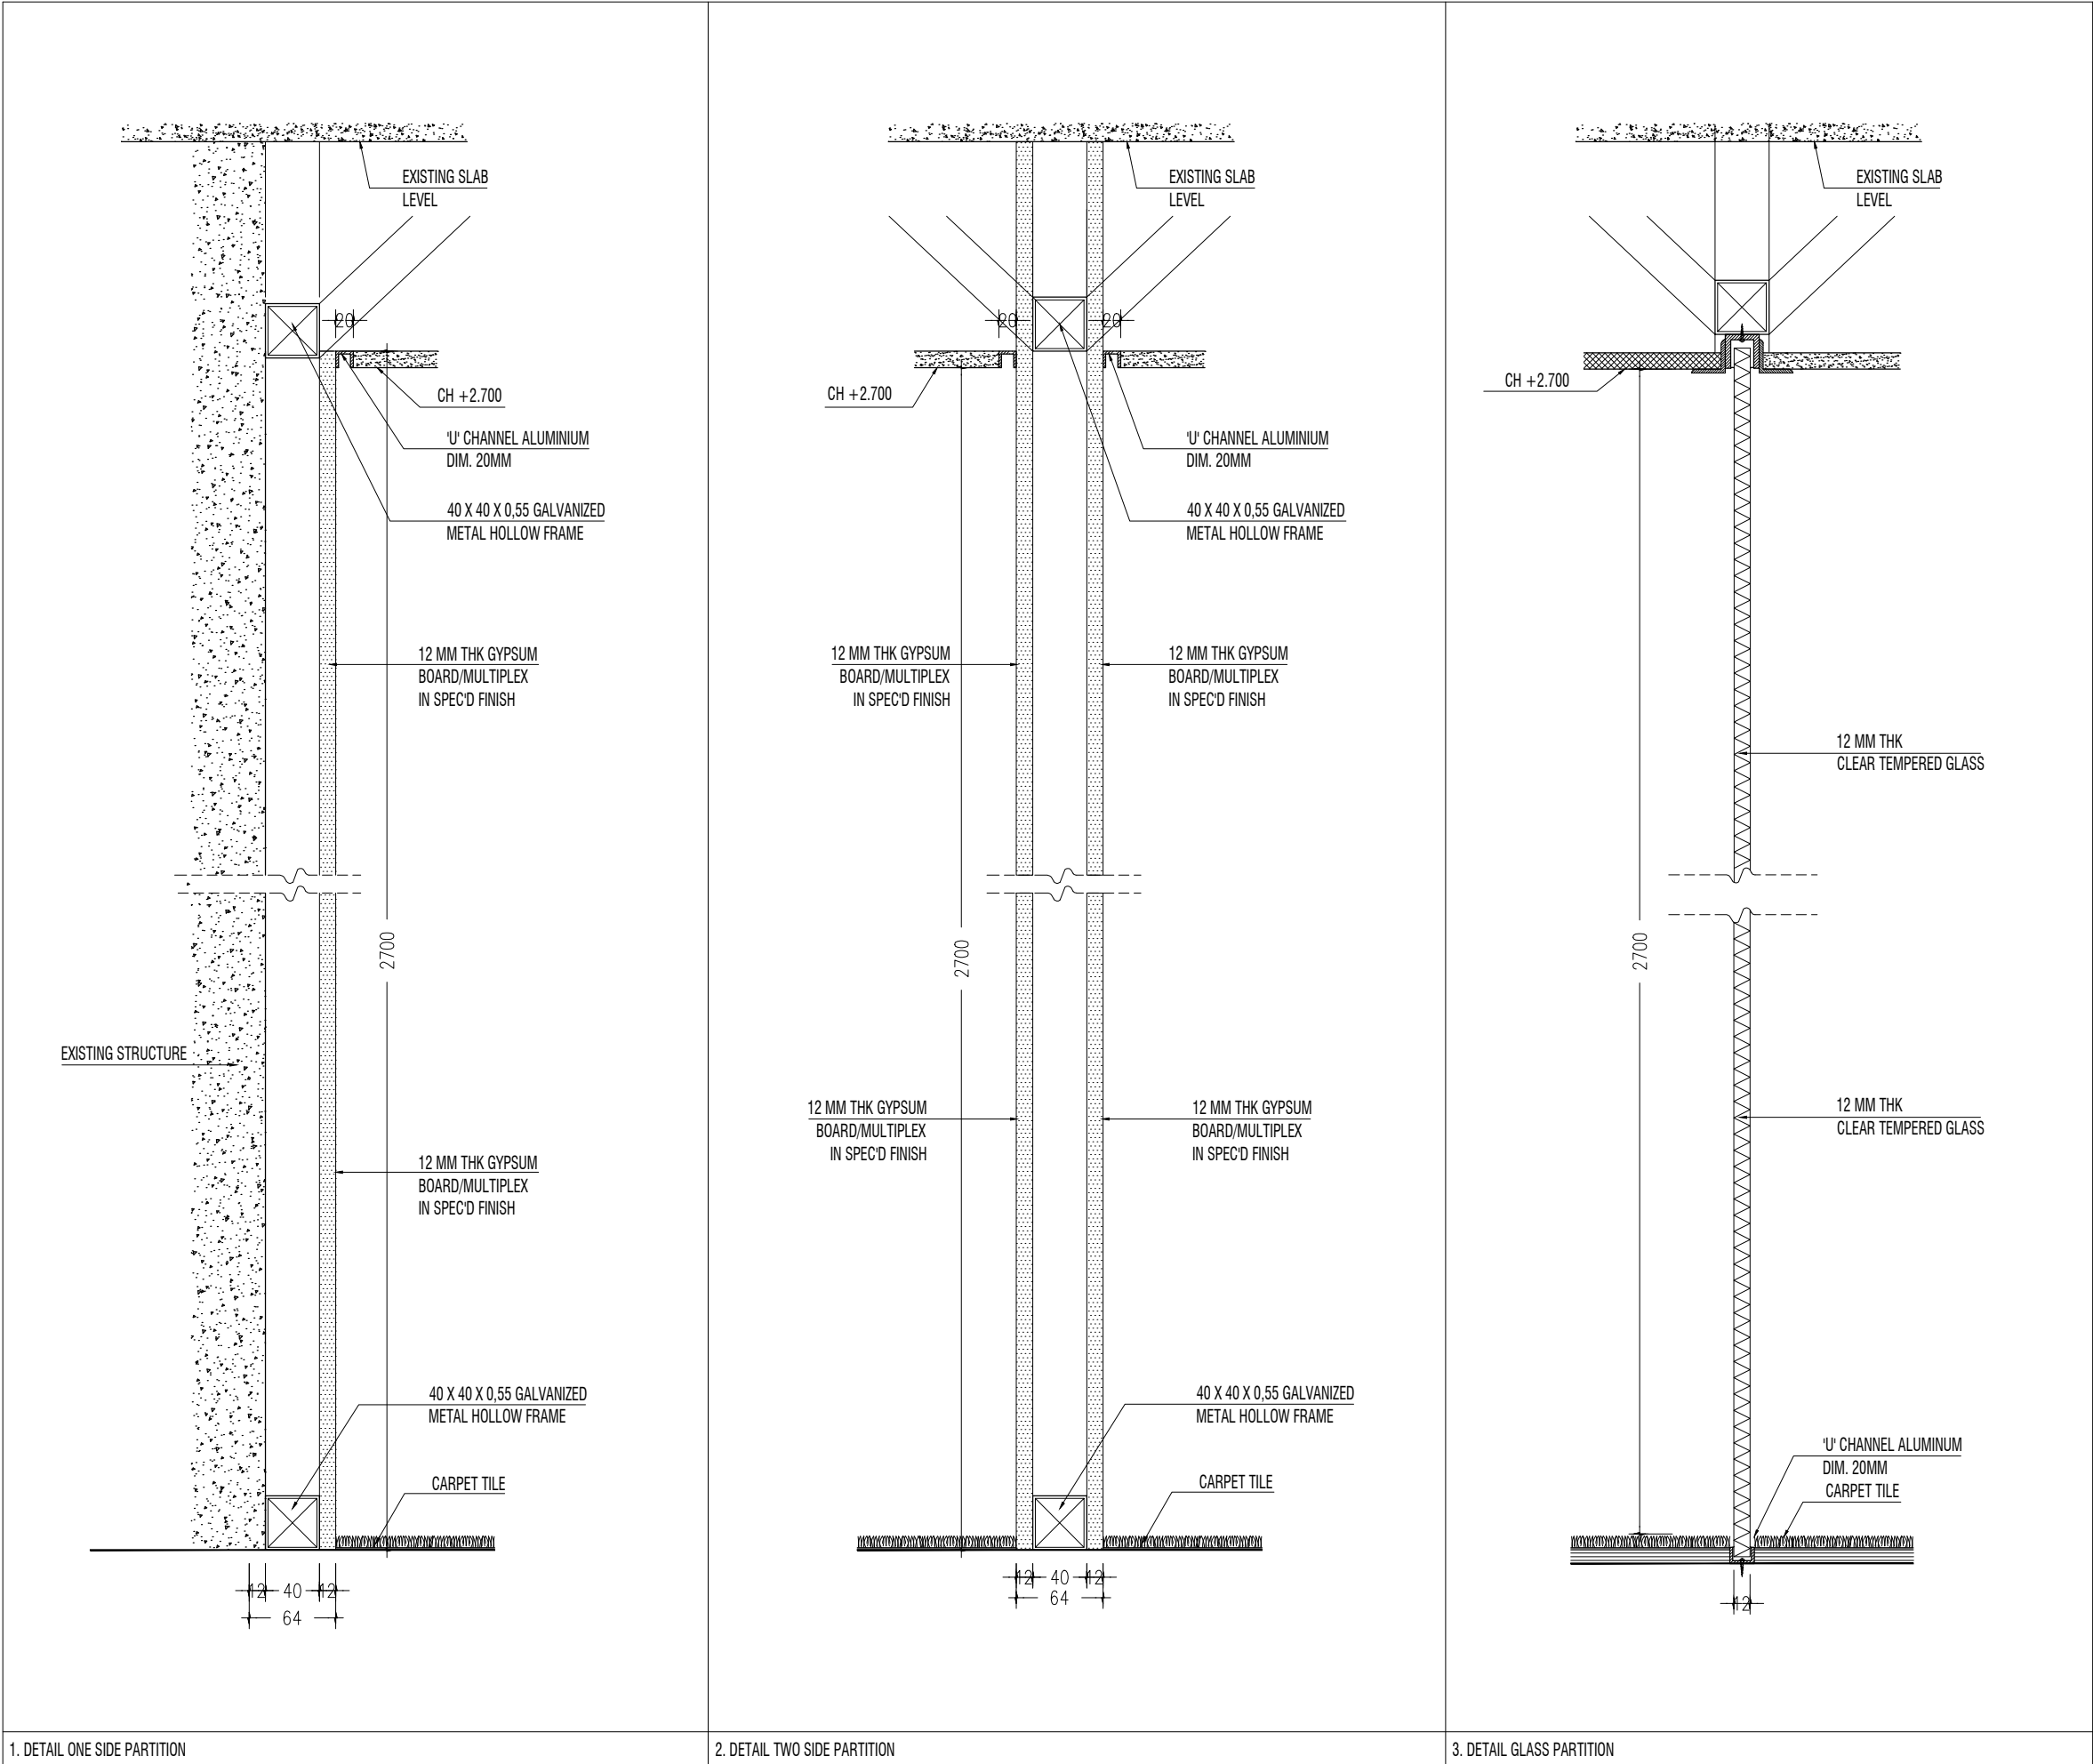


NOTE :	
CLIENT	
UNRC	
PROJECT	
UNRC OFFICE	
DRAWING TITLE	
GENERAL DETAIL (1)	
DRAWING No.	REVISION
1920 ID-101	-
SCALE NTS	CHECKED AA
DATE MAY 2019	DRAWN BP

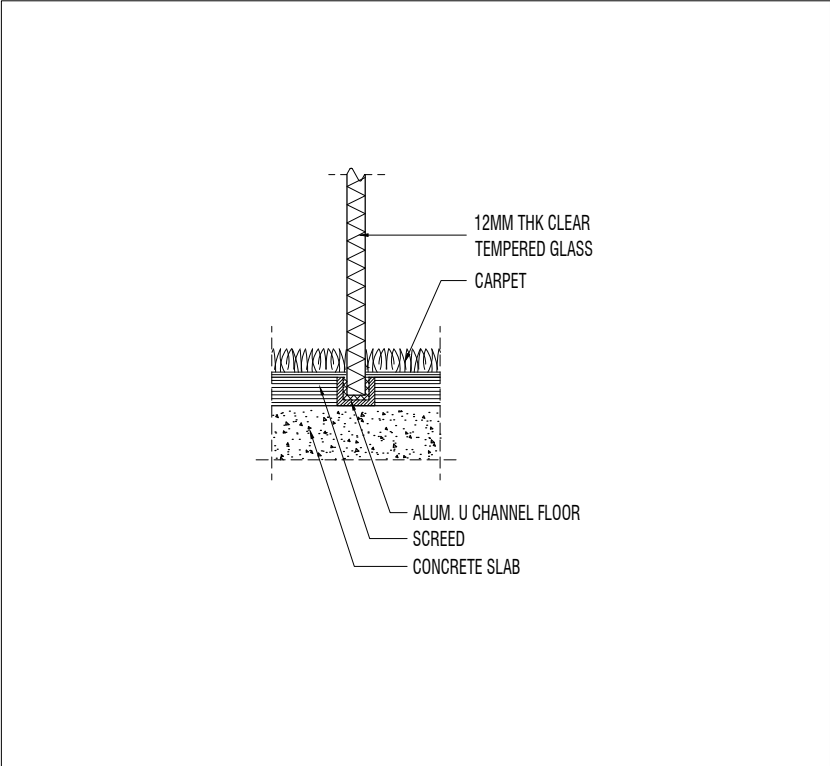

12MM THK CLEAR
TEMPERED GLASS

MITTER JOINT
W/ SEALANT
5-10MM

12MM THK CLEAR
TEMPERED GLASS

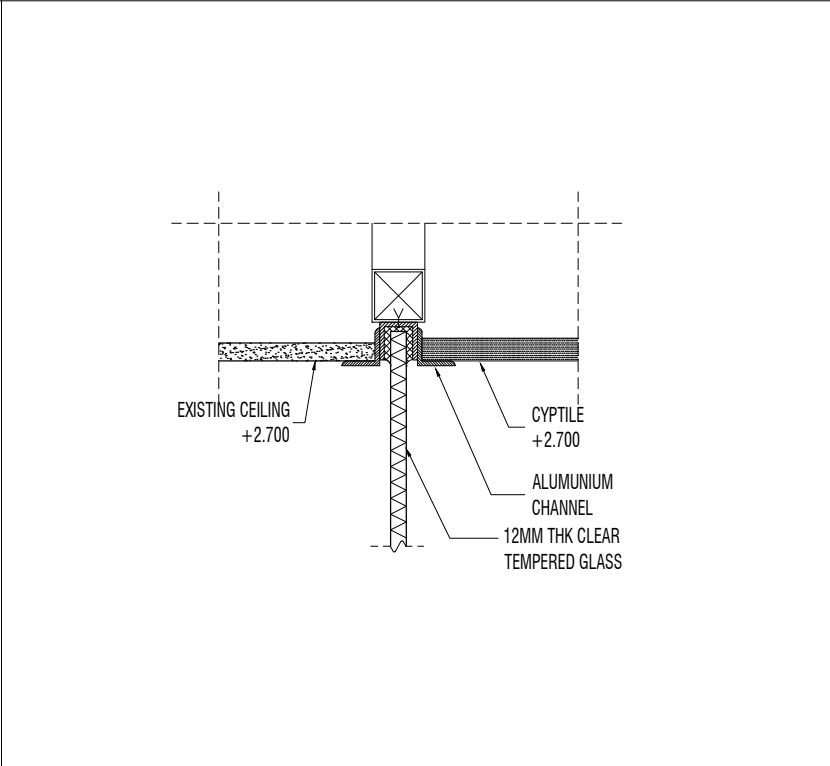

Technical drawing of a window frame cross-section. The drawing shows a vertical section of a window frame with dimensions and material specifications.

Dimensions:

- Top horizontal dimension: 64 (total), 40 (central opening), 12 (left offset), 12 (right offset).
- Left vertical dimension: 64 (total), 40 (central opening), 12 (top offset), 12 (bottom offset).
- Bottom horizontal dimension: 12 (left offset), 40 (central opening), 12 (right offset).

Materials and Components:

- 12MM THK GYPSUM BOARD IN SPEC'D FINISH (Top and side panels)
- HOLLOW 20x40mm (Central opening)
- 12MM THK GYPSUM BOARD IN SPEC'D FINISH (Bottom panel)
- ALUM. U CHANNEL 13X25 MM (Bottom support)
- 12MM THK CLEAR TEMPERED GLASS (Bottom panel)

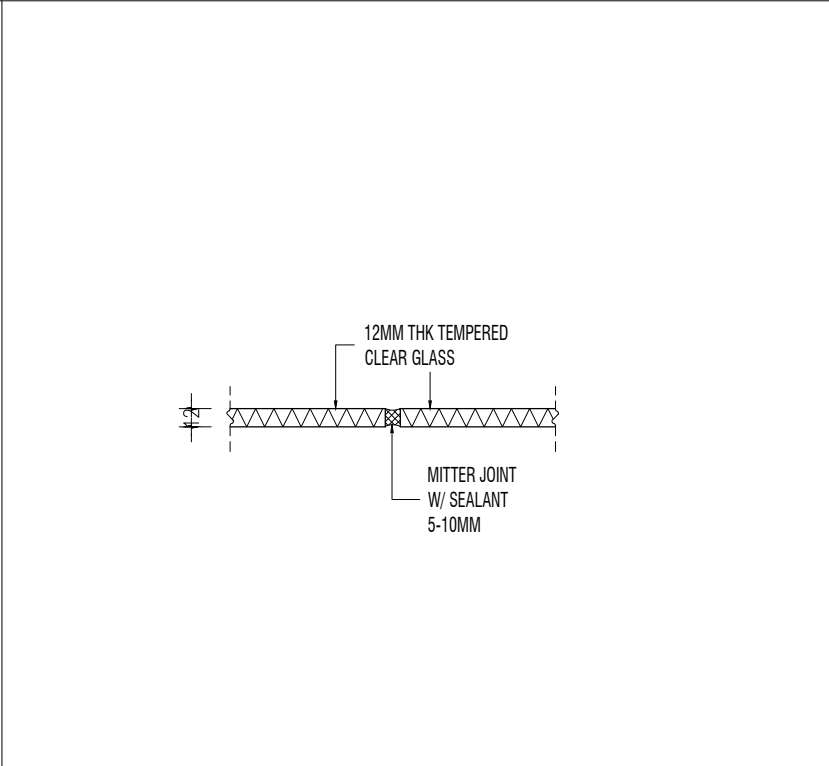


Diagram illustrating the cross-section of a window assembly with the following components and dimensions:

- HOLLOW FRAME 20x40MM
- 12MM THK CLEAR TEMPERED GLASS
- ALUM. U CHANNEL 13X25 MM
- ROCKWOLL
- 12X2 MM THK GYPSUM BOARD IN SPEC'D FIN.

Dimensions (mm):

- 40
- 64
- 5



UNRC

UNRC OFFICE

DRAWING TITLE

GENERAL DETAIL (2)


DRAWING No.	REVISION
-------------	----------

1920 ID-102	-
-------------	---

SCALE NTS	CHECKED AA
-----------	------------


DATE	MAY 2019	DRAWN	BP
------	----------	-------	----

DRAWN	BP
-------	----

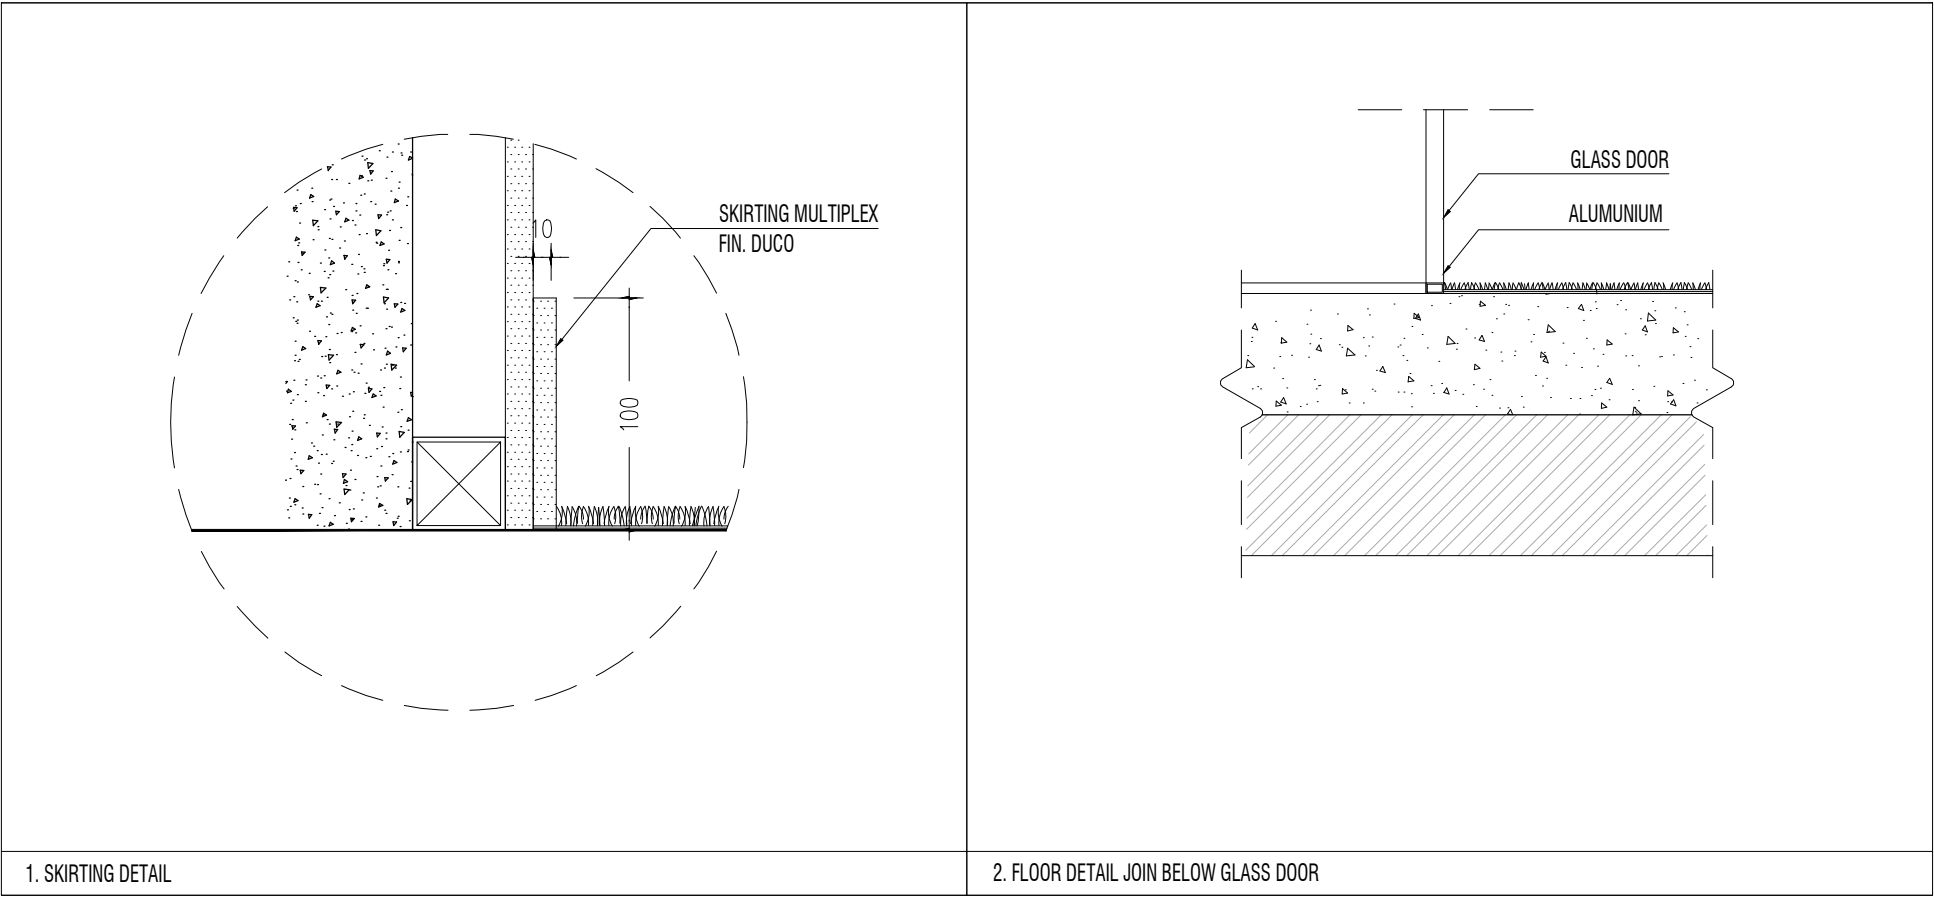

NOTE :

CLIENT	
UNRC	
PROJECT	
UNRC OFFICE	
DRAWING TITLE	
GENERAL DETAIL (3)	
DRAWING No.	REVISION
1920 ID-103	-
SCALE NTS	CHECKED AA
DATE MAY 2019	DRAWN BP

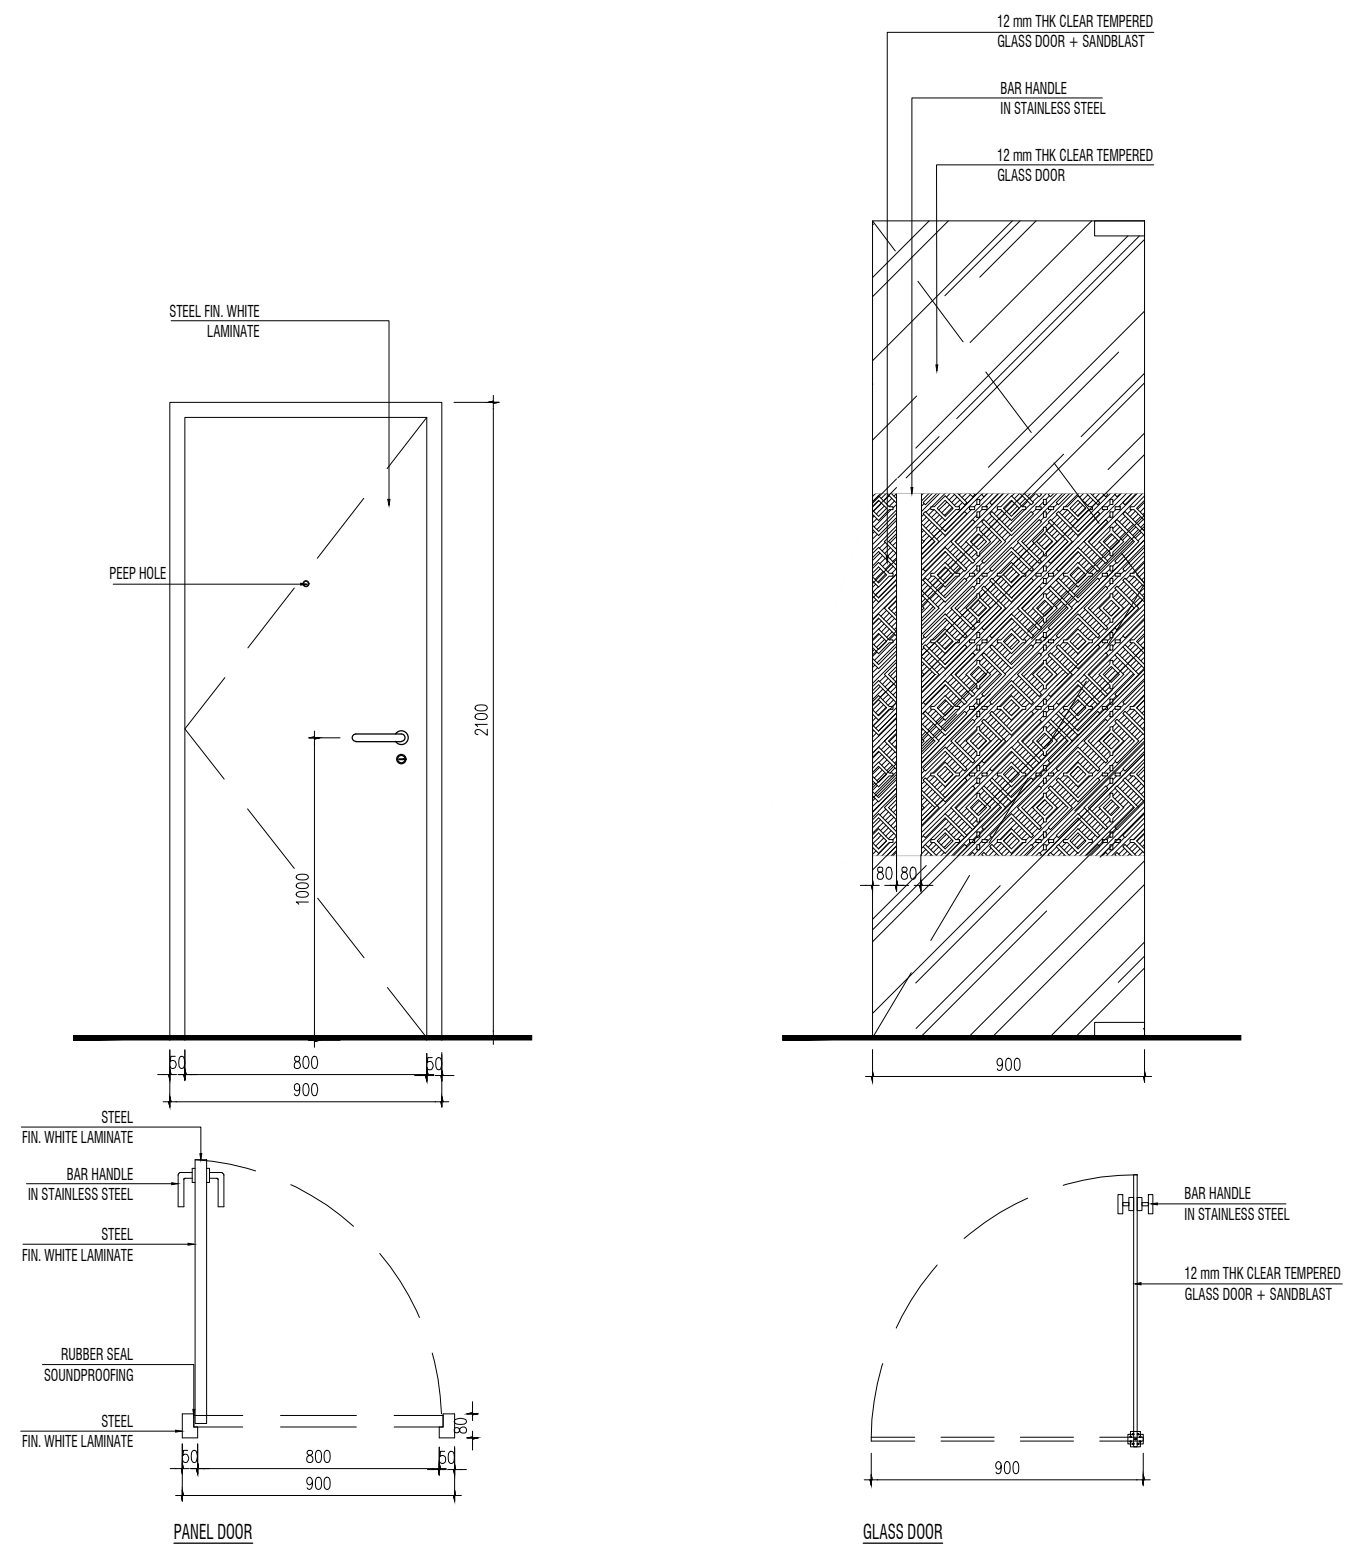

NOTE :

CLIENT

UNRC


PROJECT

UNRC OFFICE

DRAWING TITLE

DOOR DETAIL

DRAWING No.	REVISION
1920 ID-104	-
SCALE 1:25	CHECKED AA
DATE MAY 2019	DRAWN BP



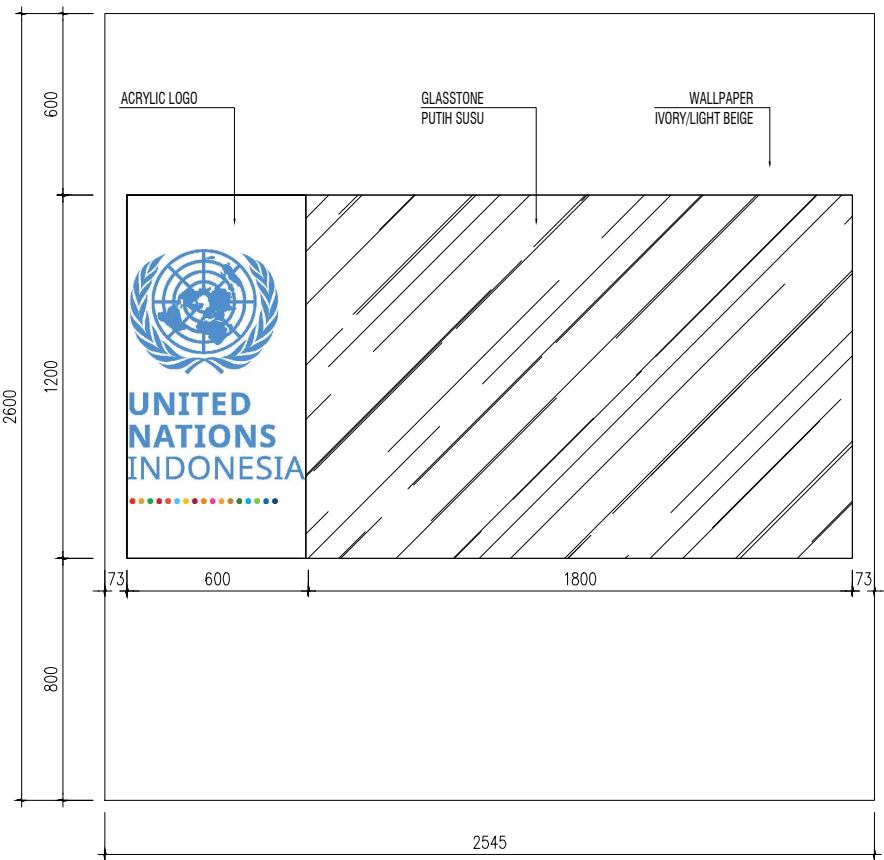


LOGO AND GLASSBOARD ELEVATION







NOTE :

CLIENT	
UNRC	
PROJECT	
UNRC OFFICE	
DRAWING TITLE	
LOGO AND GLASSBOARD DETAIL	
DRAWING No.	REVISION
1920 ID-105	-
SCALE 1:25	CHECKED AA
DATE MAY 2019	DRAWN BP

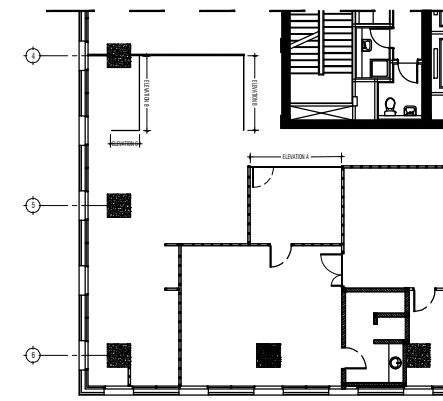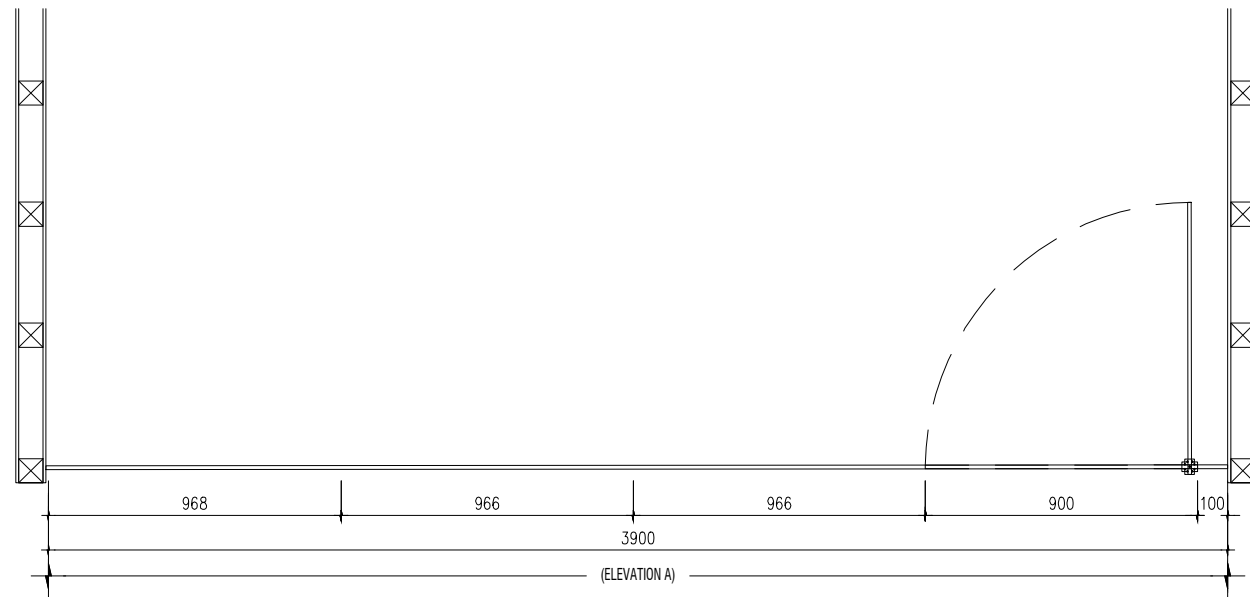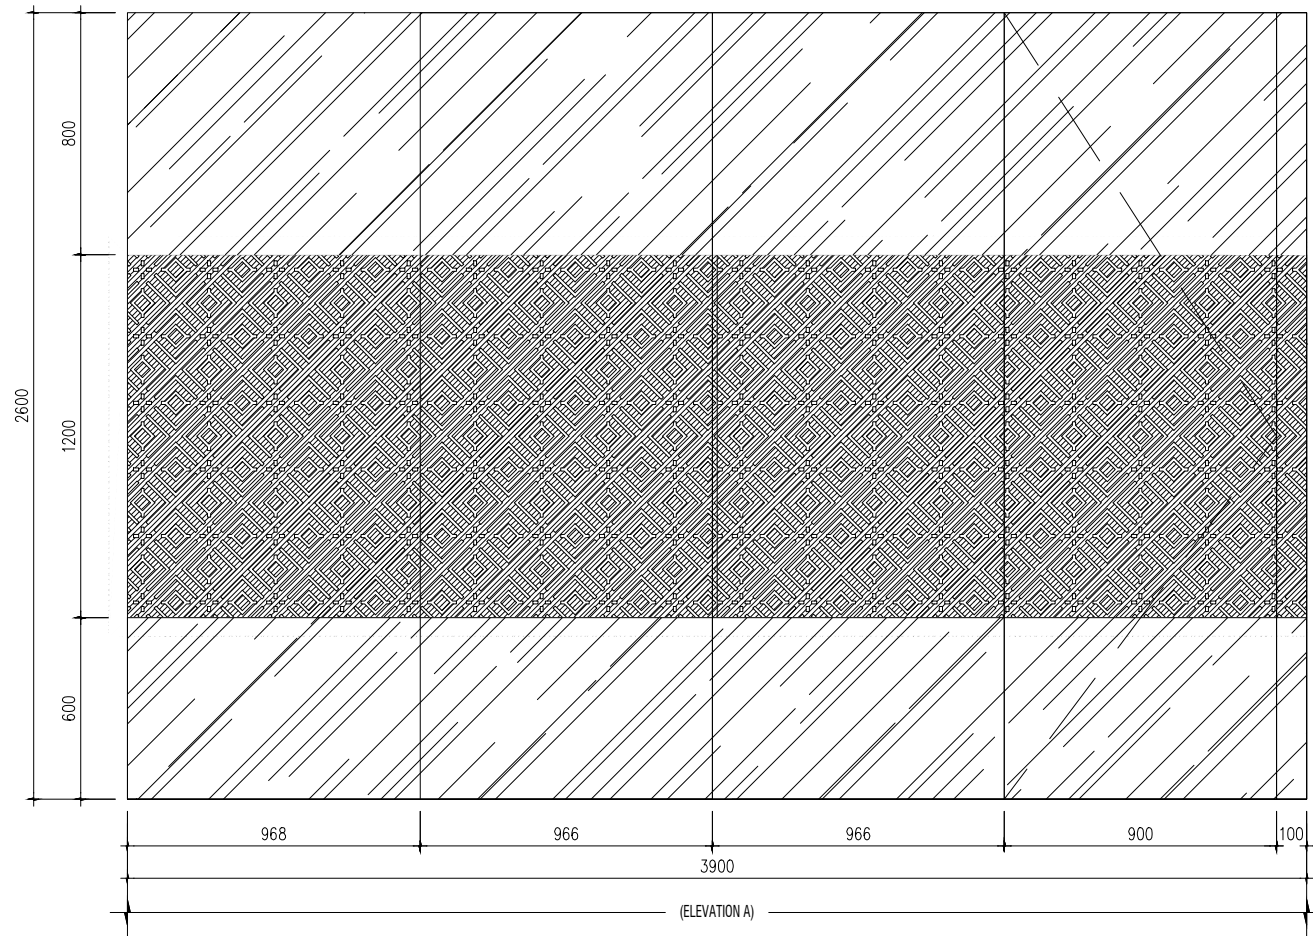


NOTE :

CLIENT	
UNRC	
PROJECT	
UNRC OFFICE	
DRAWING TITLE	
SANDBLAST DETAIL (1)	
DRAWING No.	REVISION
1920 ID-106	-
SCALE 1:25	CHECKED AA
DATE MAY 2019	DRAWN BP

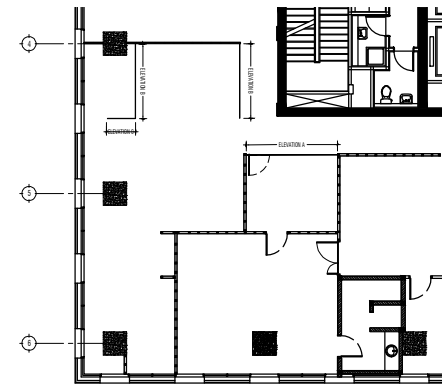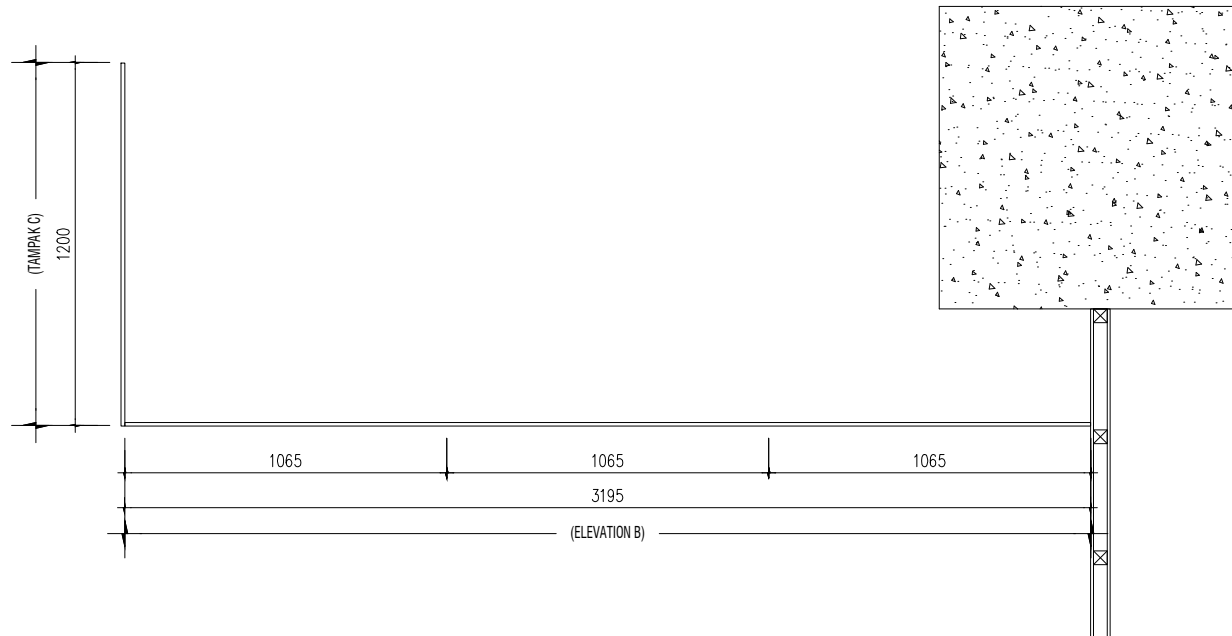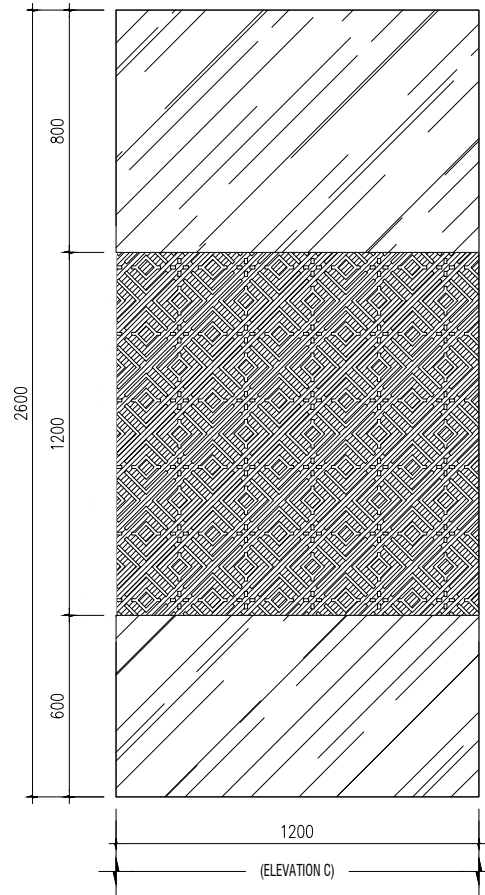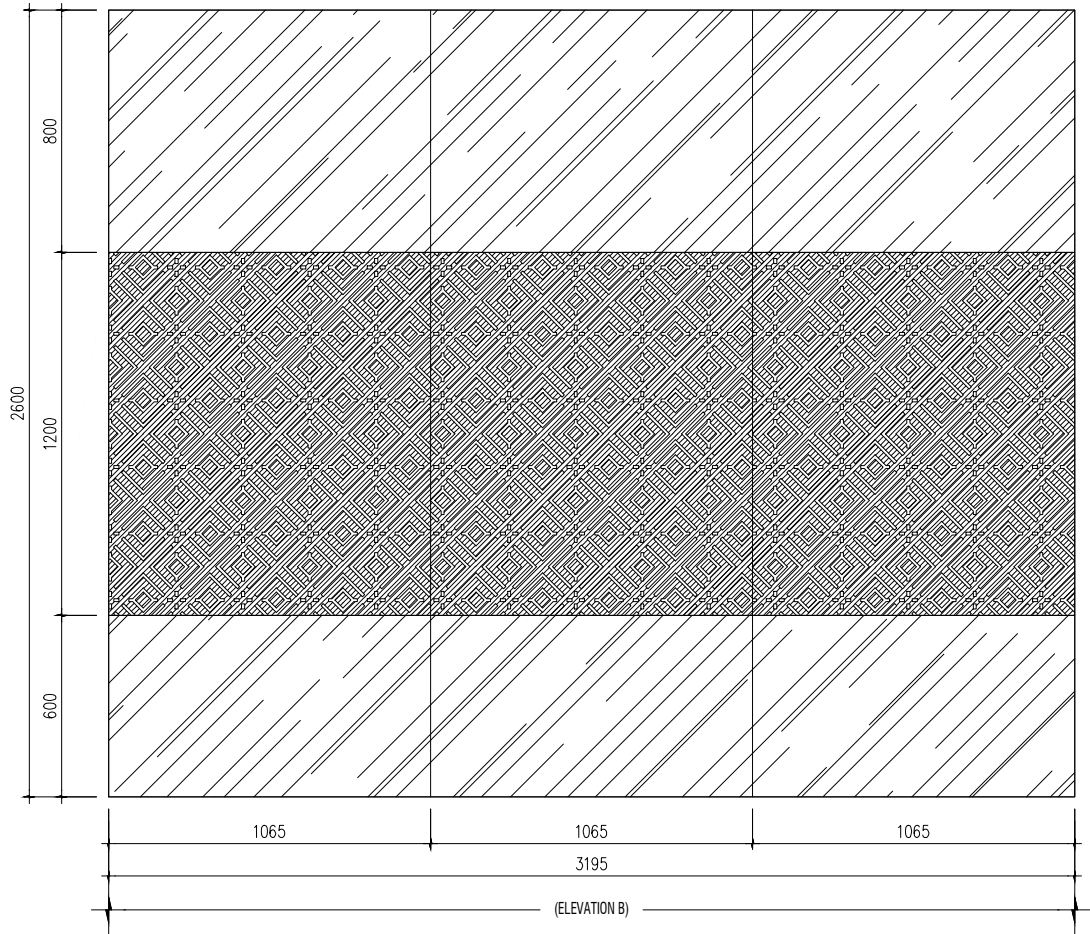

NOTE :


CLIENT	
UNRC	
PROJECT	
UNRC OFFICE	
DRAWING TITLE	
SANDBLAST DETAIL (2)	
DRAWING No.	REVISION
1920 ID-107	-
SCALE 1:25	CHECKED AA
DATE MAY 2019	DRAWN BP

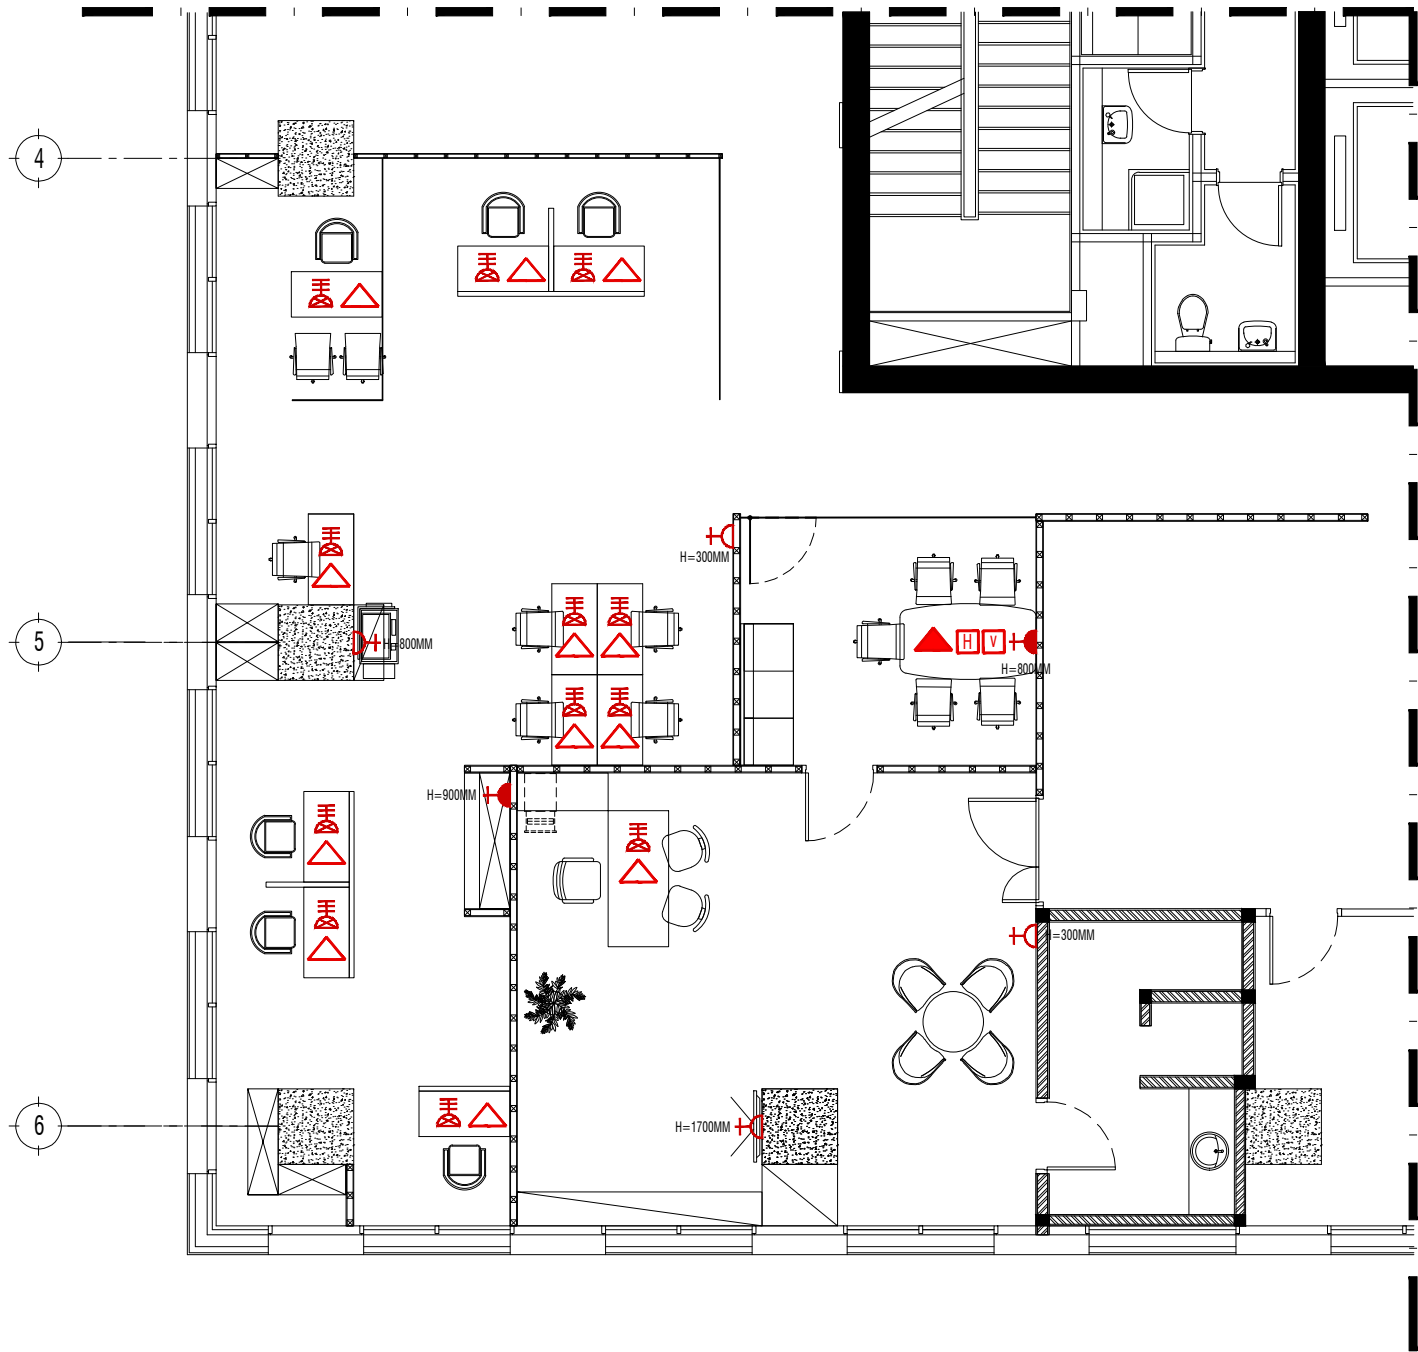

- NOTE :
- △ DATA (BELOW DESK)
 - ▲ DATA (ON DESK)
 - H HDMI (ON DESK)
 - V VGA (ON DESK)
 - ⬆ 1 POWER OUTLET (ON FLOOR)
 - ⬆ 1 POWER OUTLET (ON WALL)
 - ⬆ 3 POWER OUTLET (ON WALL)
 - ⬆ 3 POWER OUTLET (BELOW DESK)

MEP CHECK ON SITE


CLIENT	
UNRC	
PROJECT	
UNRC OFFICE	
DRAWING TITLE	
POWER PLAN	
DRAWING No.	REVISION
1920 MEP-101	-
SCALE 1:100	CHECKED AA
DATE MAY 2019	DRAWN BP

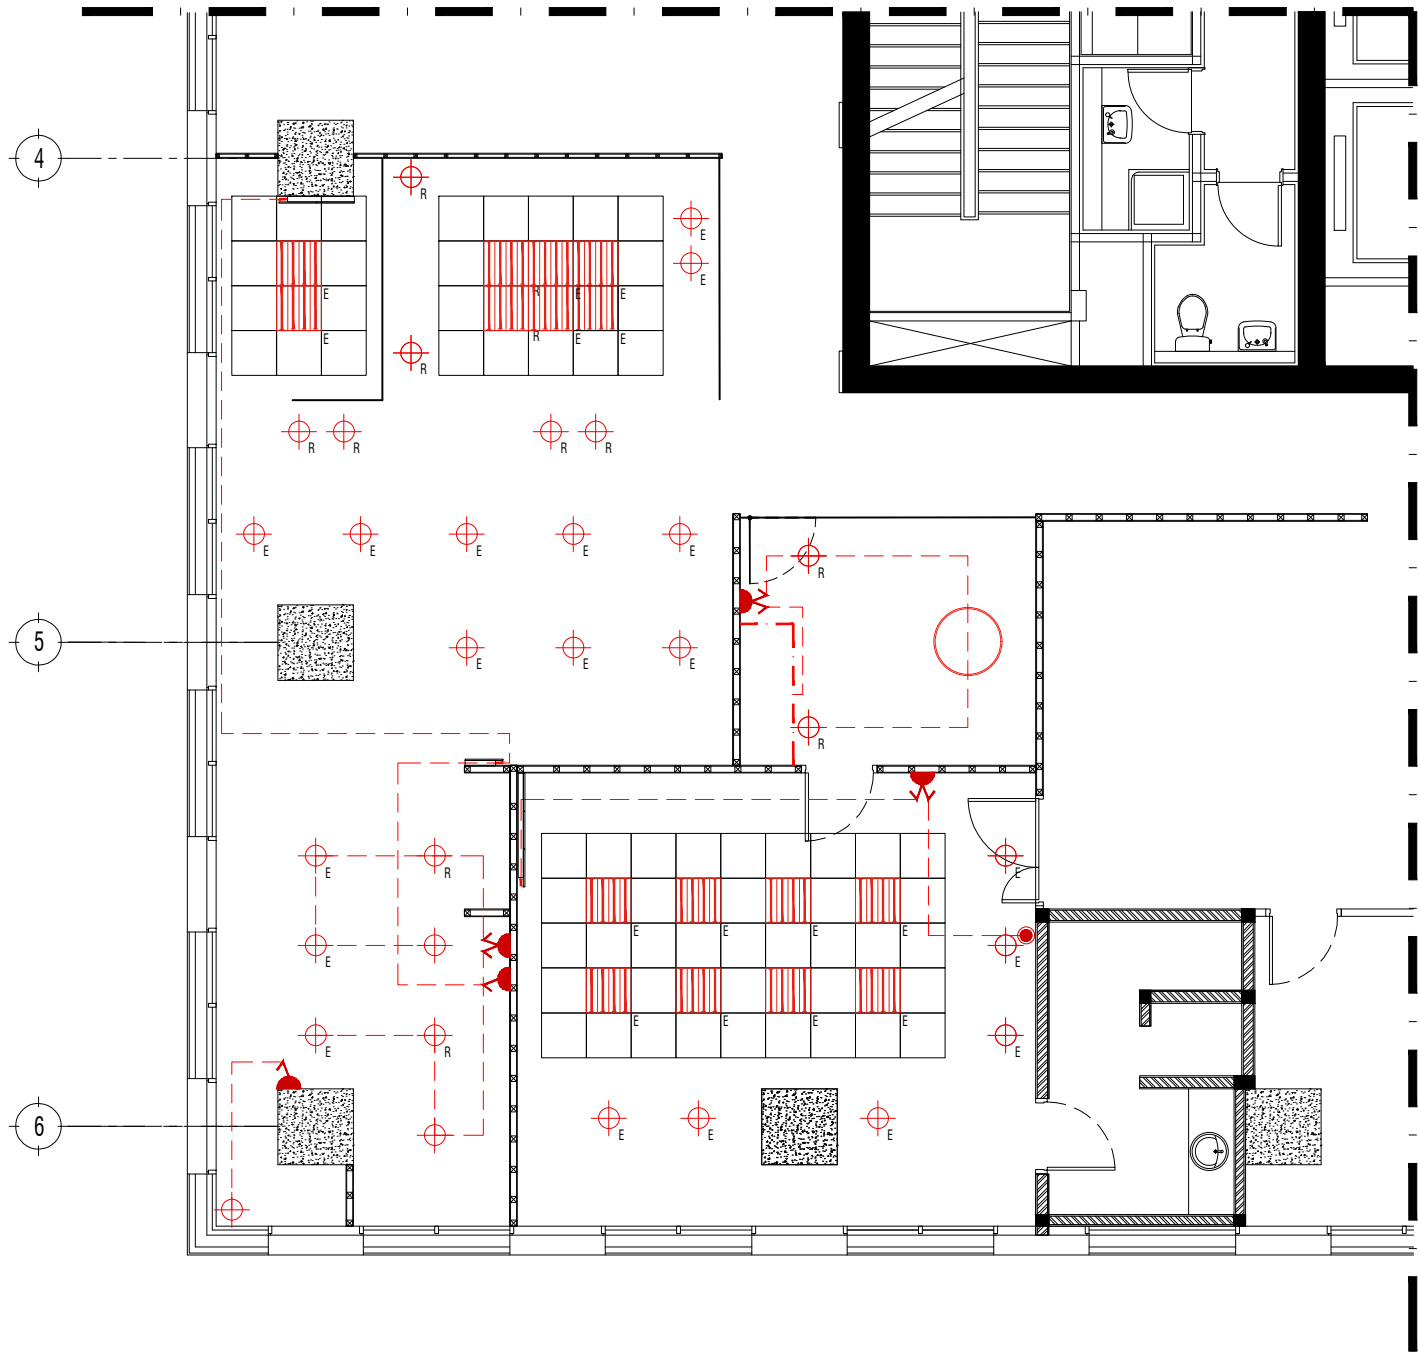

NOTE :

-  SINGLE SWITCH
-  DOUBLE SWITCH
-  RM LIGHT (EXISTING)
-  RM LIGHT (RELOCATION)
-  PENDANT LAMP
-  DOWNLIGHT (EXISTING)
-  DOWNLIGHT (RELOCATION)
-  DOWNLIGHT (NEW)
-  SPOTLIGHT
-  LED STRIP
-  WALL PANEL LED STRIP

CLIENT	
UNRC	
PROJECT	
UNRC OFFICE	
DRAWING TITLE	
LIGHTING PLAN	
DRAWING No.	REVISION
1920 MEP-102	-
SCALE 1:100	CHECKED AA
DATE MAY 2019	DRAWN BP

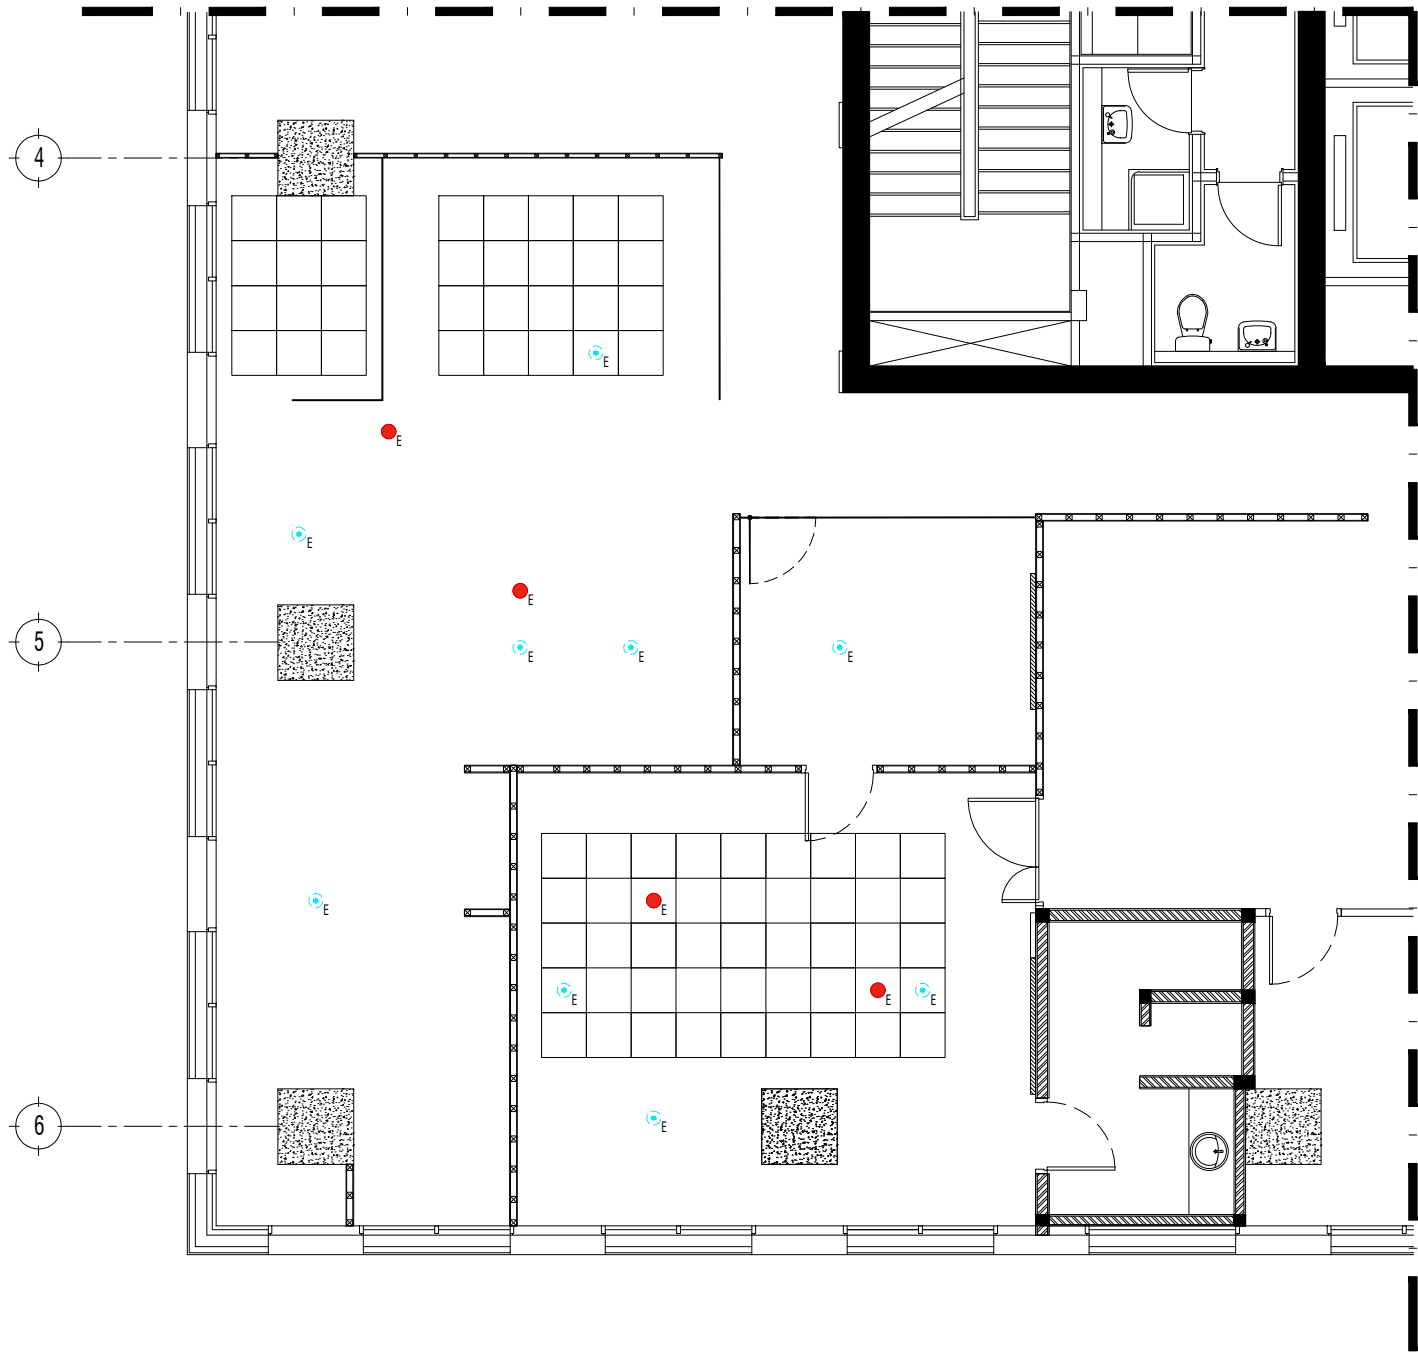


NOTE :

- E SPEAKER (EXISTING)
- E SPRINKLER (EXISTING)

MEP CHECK ON SITE

CLIENT	
UNRC	
PROJECT	
UNRC OFFICE	
DRAWING TITLE	
SPRINKLER, SMOKE DETECTOR, & SPEAKER PLAN	
DRAWING No.	REVISION
1920 MEP-103	-
SCALE 1:100	CHECKED AA
DATE MAY 2019	DRAWN BP

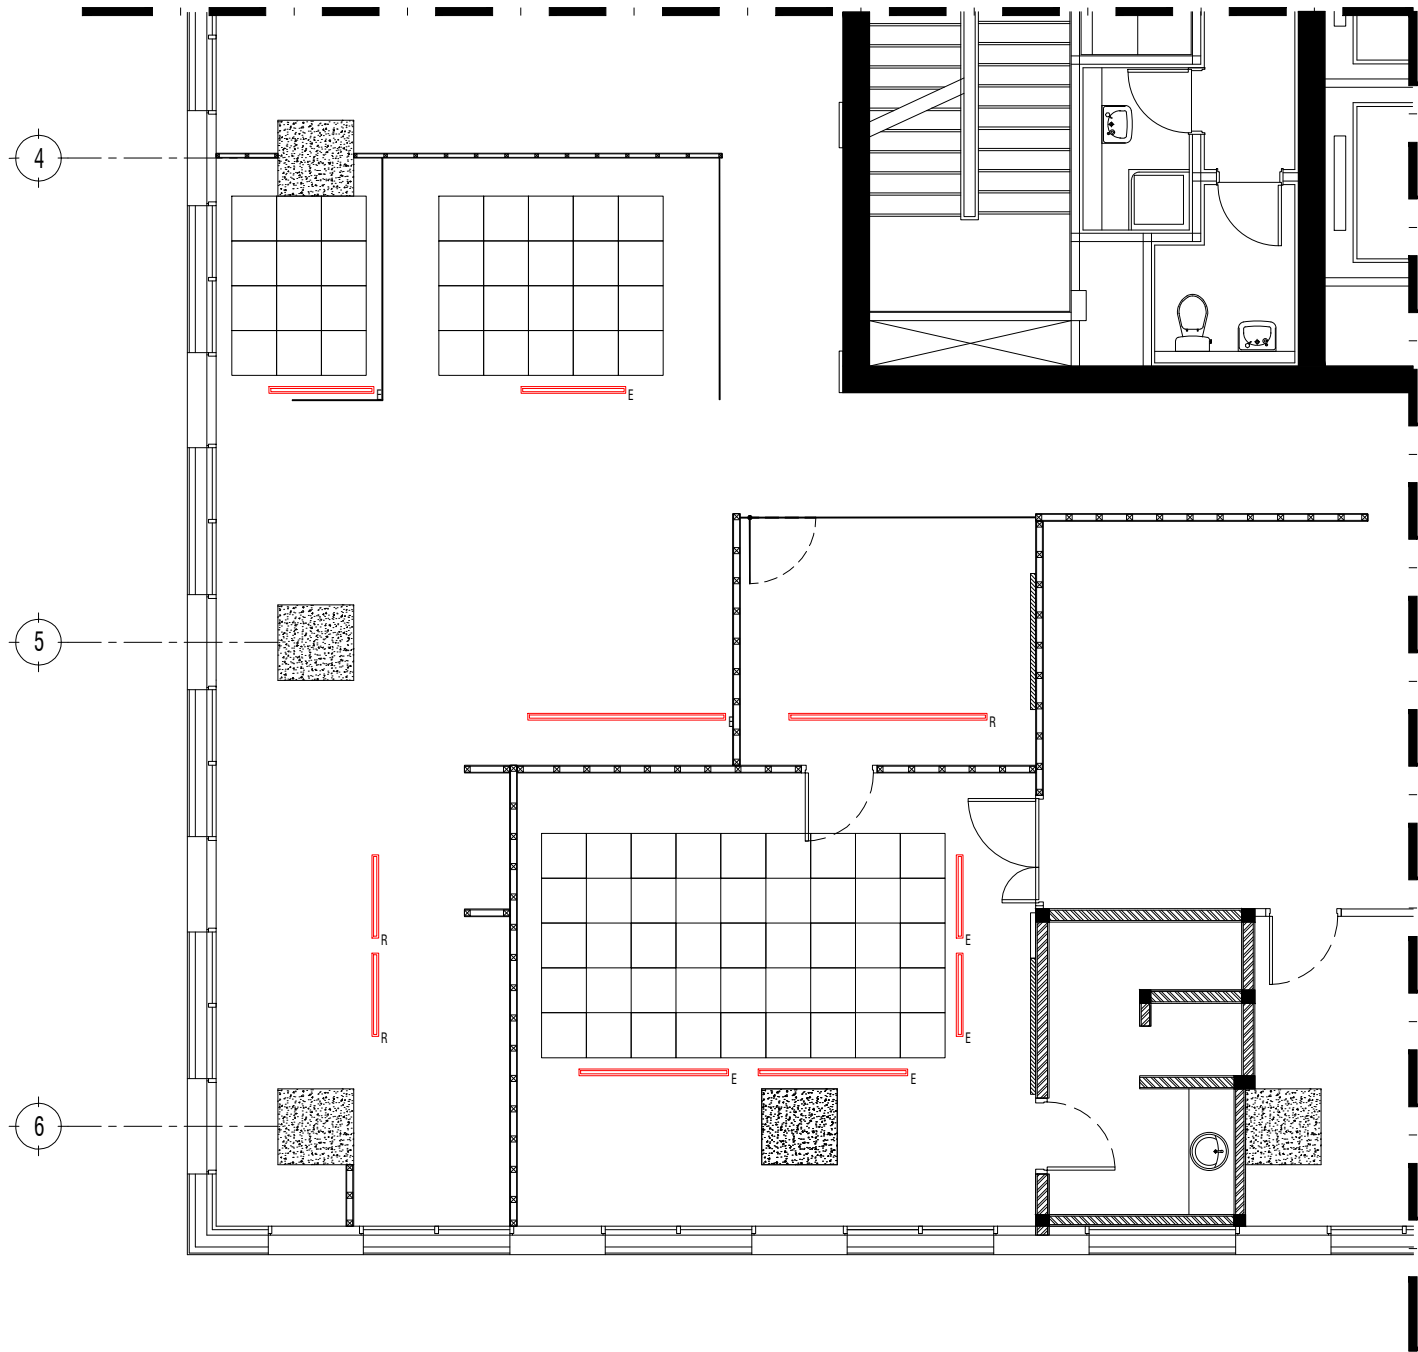


NOTE :

- E— LINEAR AC (EXISTING)
- R— LINEAR AC (RELOCATION)

MEP CHECK ON SITE

CLIENT	
UNRC	
PROJECT	
UNRC OFFICE	
DRAWING TITLE	
AC PLAN	
DRAWING No.	REVISION
1920 MEP-104	-
SCALE 1:100	CHECKED AA
DATE MAY 2019	DRAWN BP

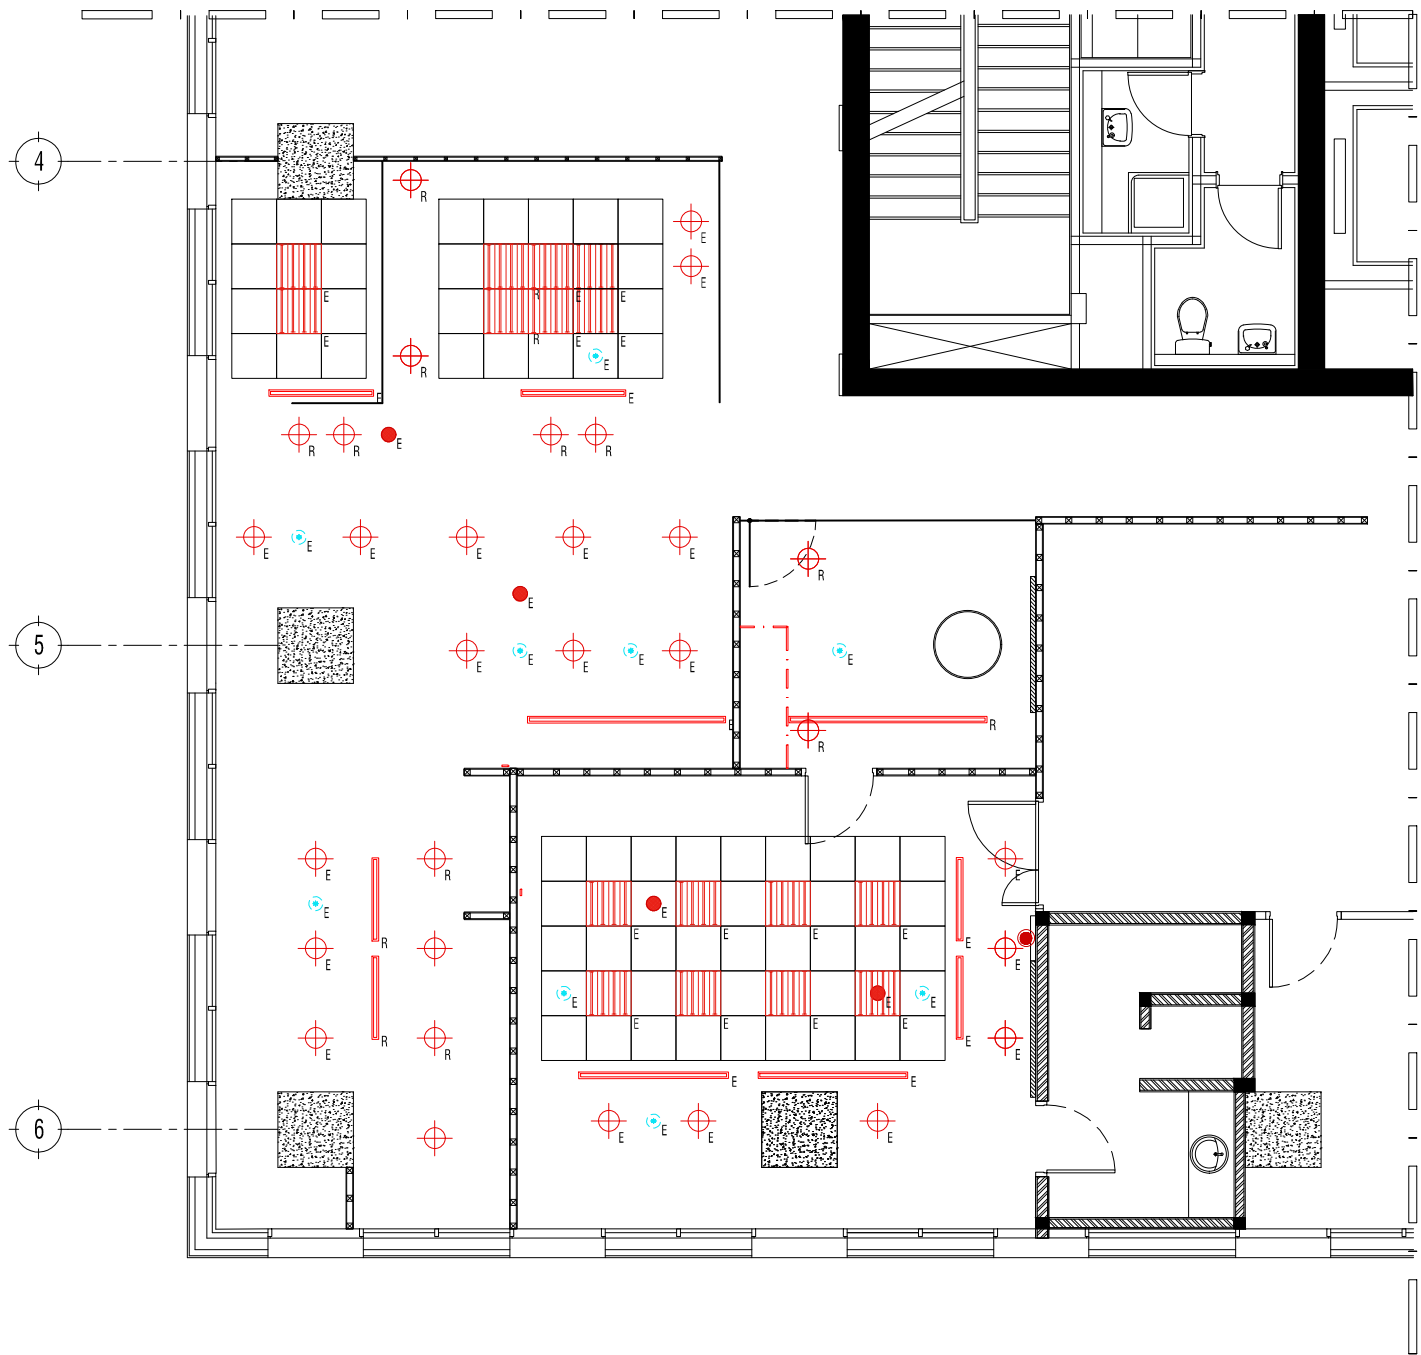


NOTE :

- LINEAR AC (EXISTING)
- LINEAR AC (RELOCATION)
- SINGLE SWITCH
- DOUBLE SWITCH
- RM LIGHT (EXISTING)
- RM LIGHT (RELOCATION)
- PENDANT LAMP
- DOWNLIGHT (EXISTING)
- DOWNLIGHT (RELOCATION)
- DOWNLIGHT (NEW)
- SPOTLIGHT
- LED STRIP
- WALL PANEL LED STRIP
- SPEAKER (EXISTING)
- SPRINKLER (EXISTING)


CLIENT	
UNRC	
PROJECT	
UNRC OFFICE	
DRAWING TITLE	
REFLECTED CEILING PLAN	
DRAWING No.	REVISION
1920 MEP-105	-
SCALE 1:100	CHECKED AA
DATE MAY 2019	DRAWN BP

WIRING DIAGRAM
UNRC OFFICE

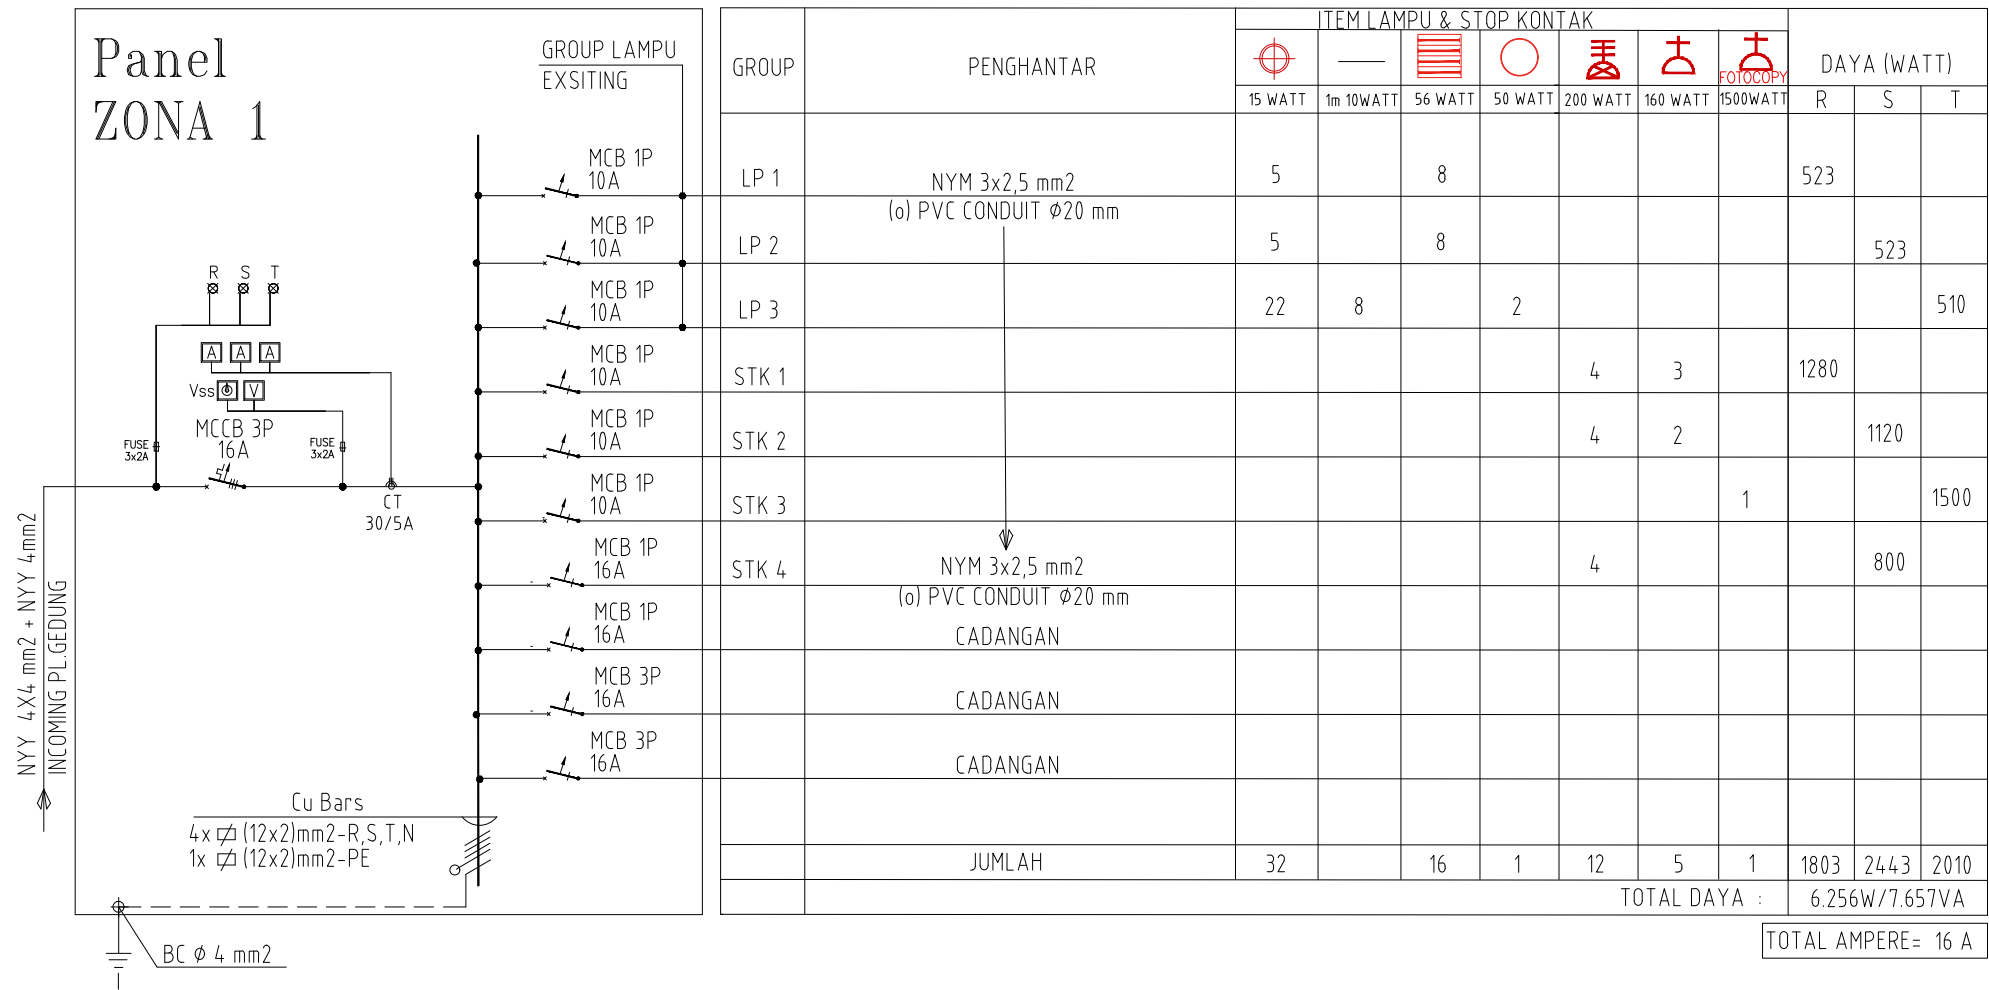


NOTE :


CLIENT	
UNRC	
PROJECT	
UNRC OFFICE	
DRAWING TITLE	
SINGLE LINE DIAGRAM	
DRAWING No.	REVISION
1920 MEP-106	-
SCALE NTS	CHECKED AA
DATE MAY 2019	DRAWN BP

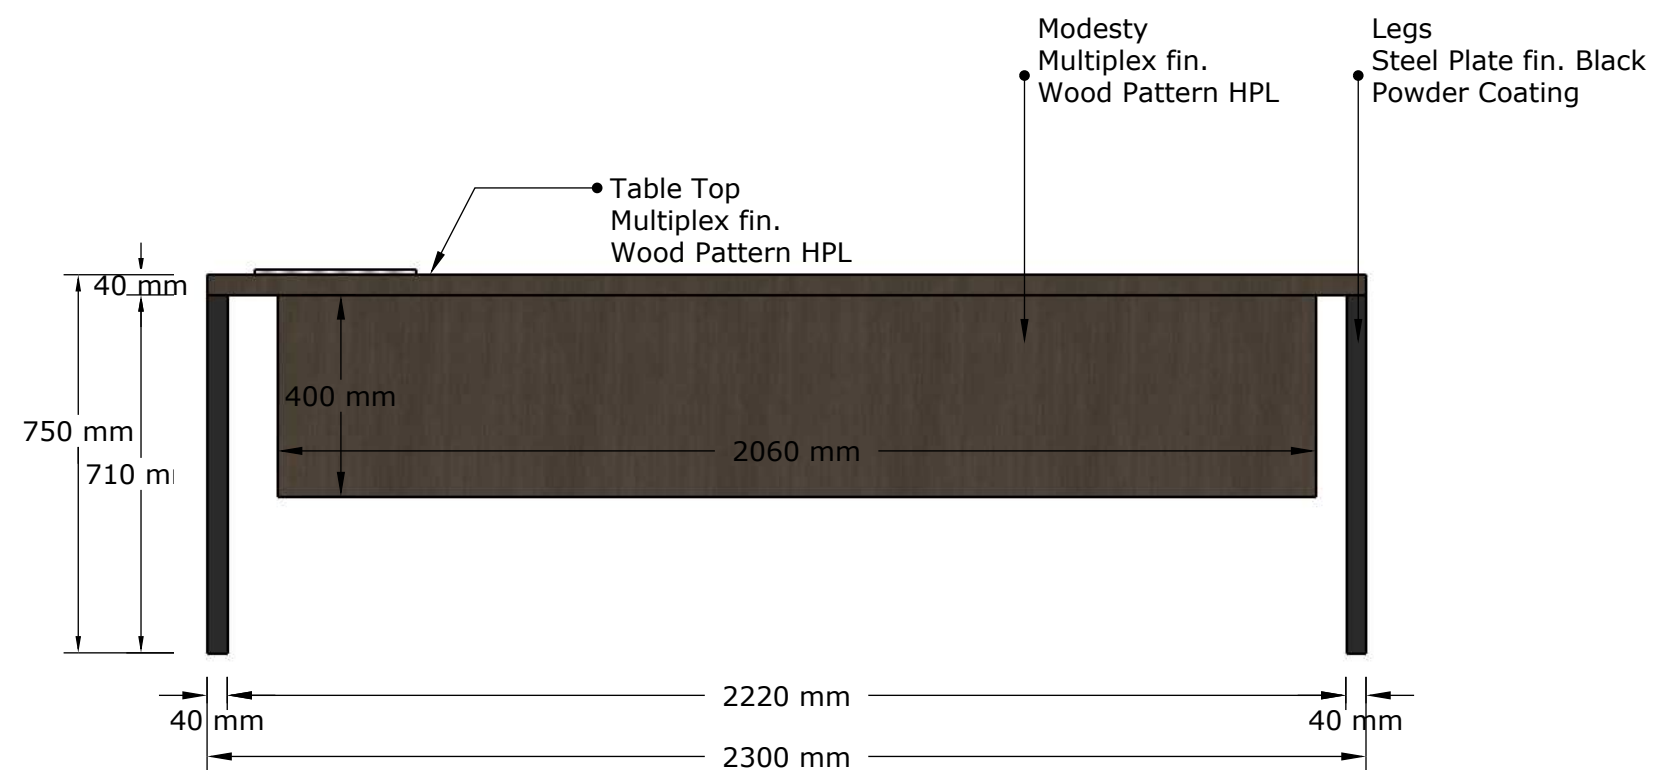

FRONT ELEVATION
SCALE 1:15

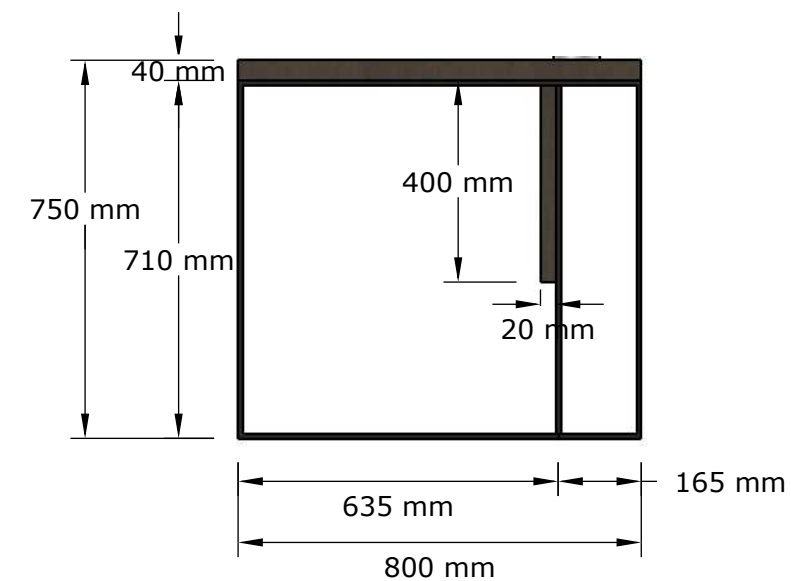

RIGHT ELEVATION
SCALE 1:15

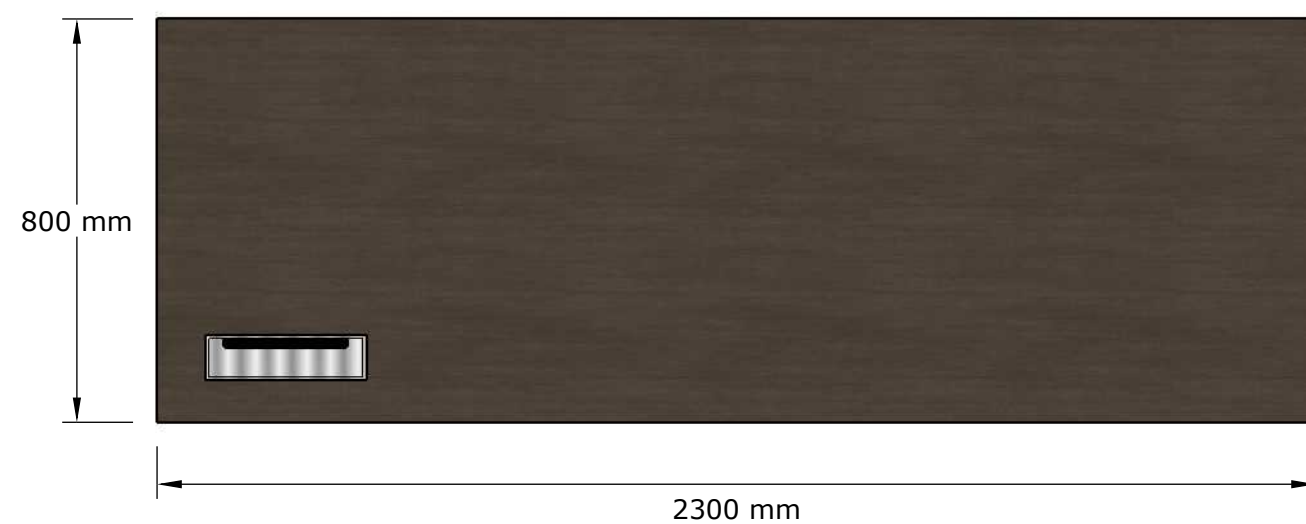

TOP VIEW
SCALE 1:15




PERSPECTIVE
SCALE NTS



PERPECTIVE VIEW
SCALE NTS

Note:
dim. 2800mm x 1200mm
Desk & partition combination
Ikea Bekant or equivalent

TB-02
STAFF WORKSTATION

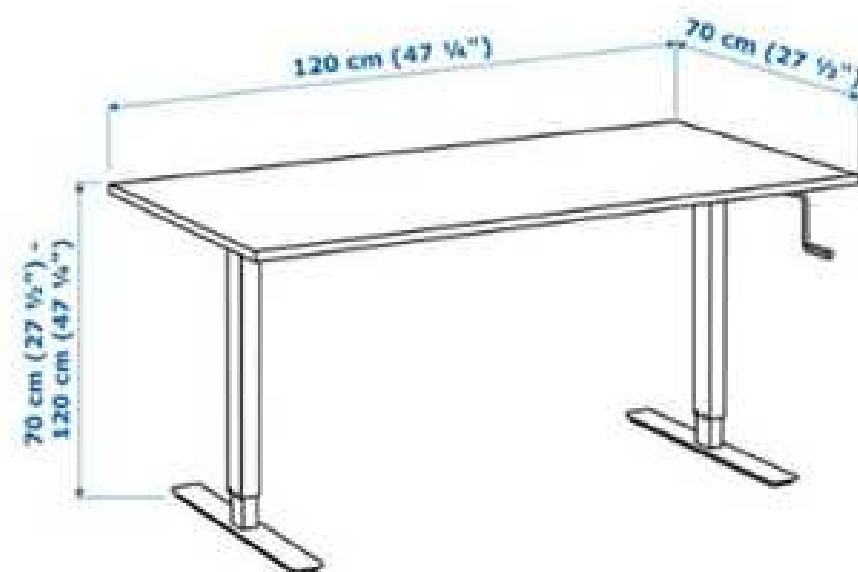

PERPECTIVE VIEW
SCALE NTS

Note:
dim. 1200mm x 700mm x 700-1200 mm
Adjustable Height, Manual
Ikea Skarsta or equivalent


TB-03
MANAGER WORKSTATION




PERPECTIVE VIEW
SCALE NTS

Note:
dim. 2800mm x 1200mm
Desk & partition combination
Ikea Bekant or equivalent


TB-06
4 STAFF WORKSTATIONS

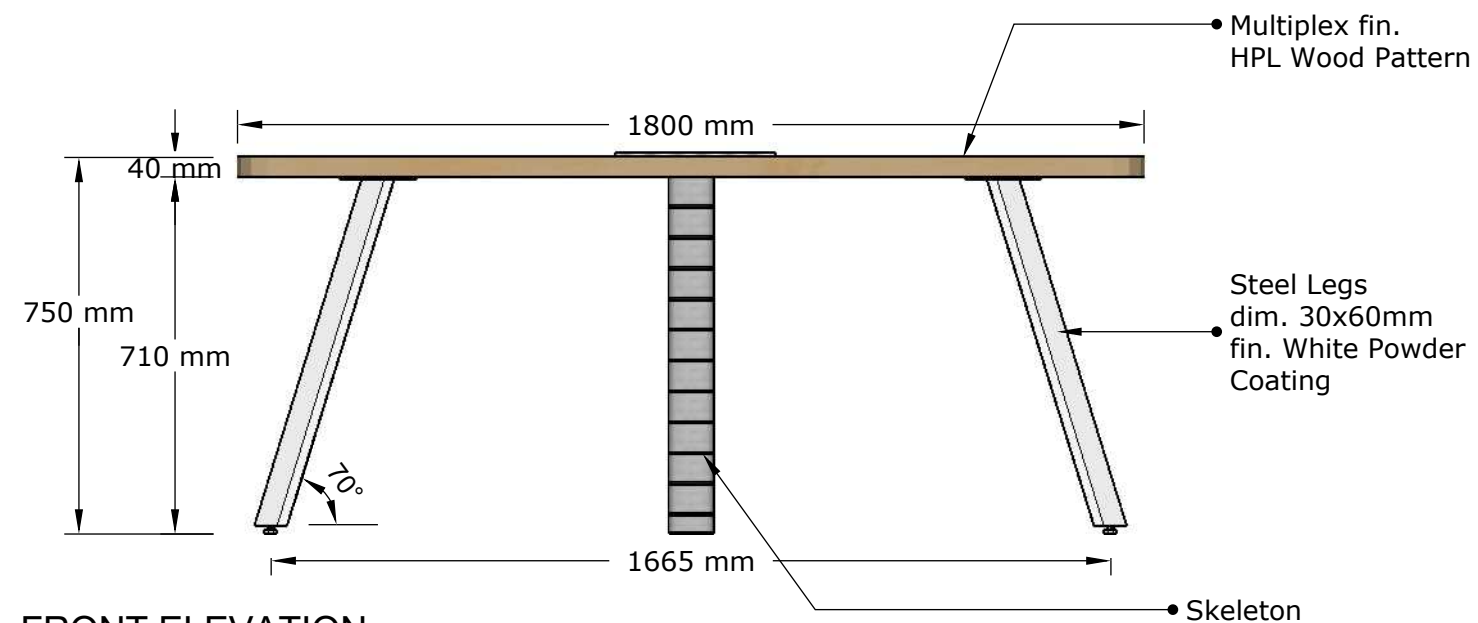


FRONT ELEVATION
SCALE 1:15

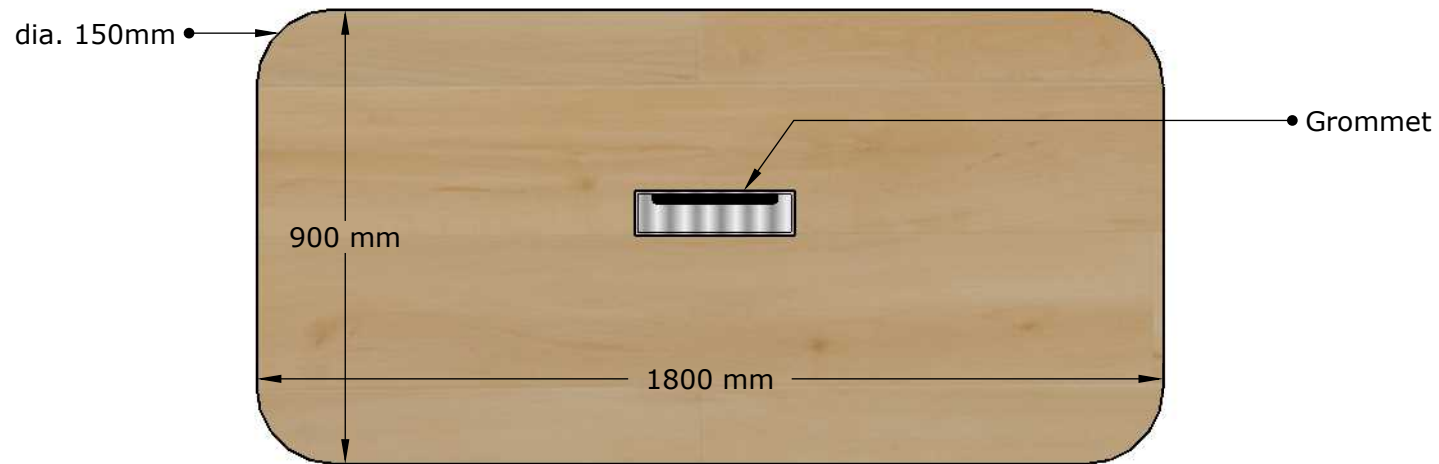

TOP VIEW
SCALE 1:15

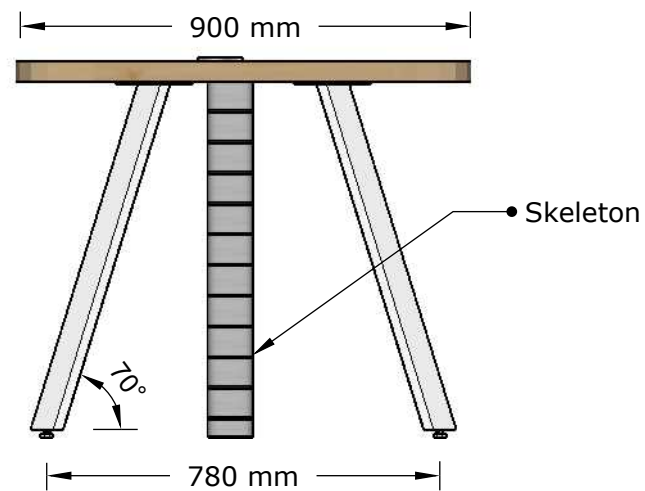


SIDE ELEVATION
SCALE 1:15

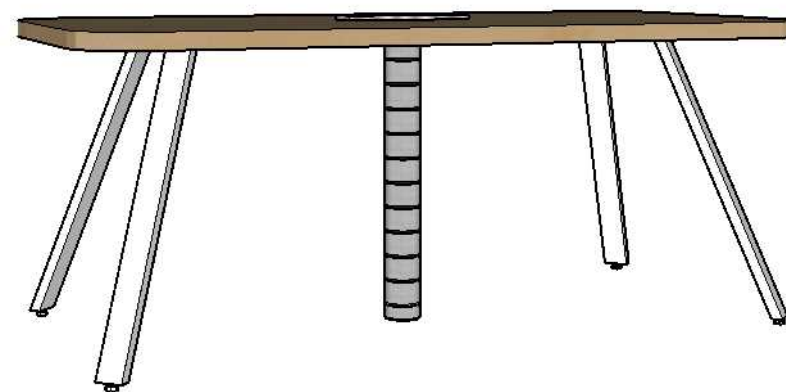


PERSPECTIVE
SCALE NTS

TB-04
MEETING TABLE

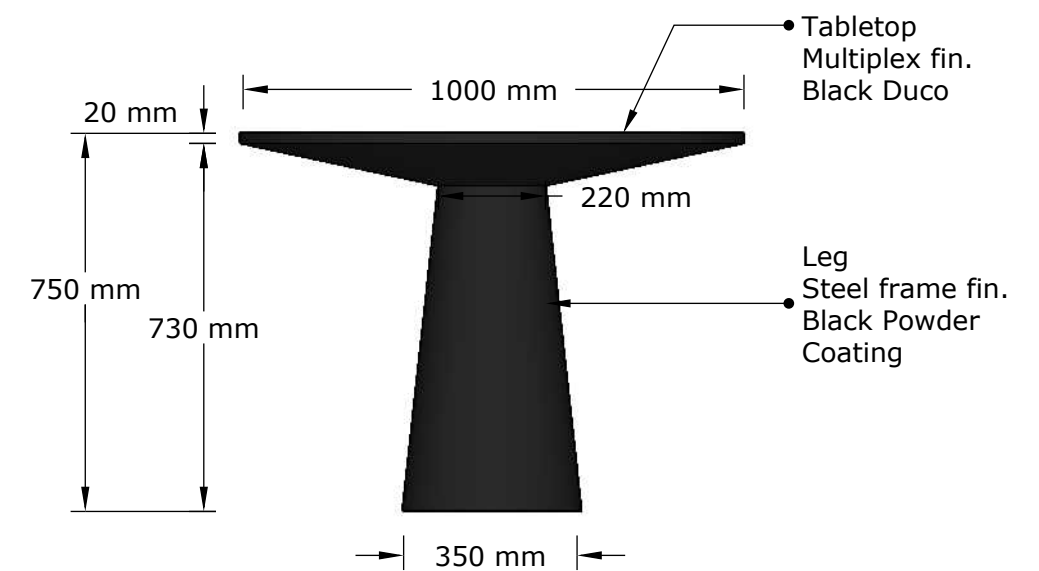

FRONT ELEVATION
SCALE 1:15

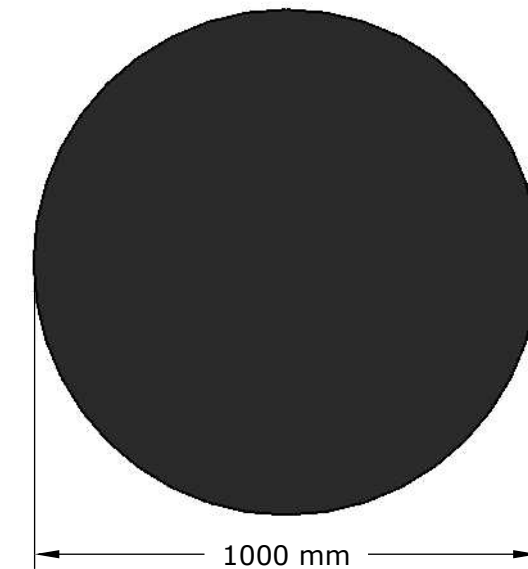


TOP VIEW
SCALE 1:15




PERSPECTIVE
SCALE NTS


TB-05
DISCUSSION TABLE

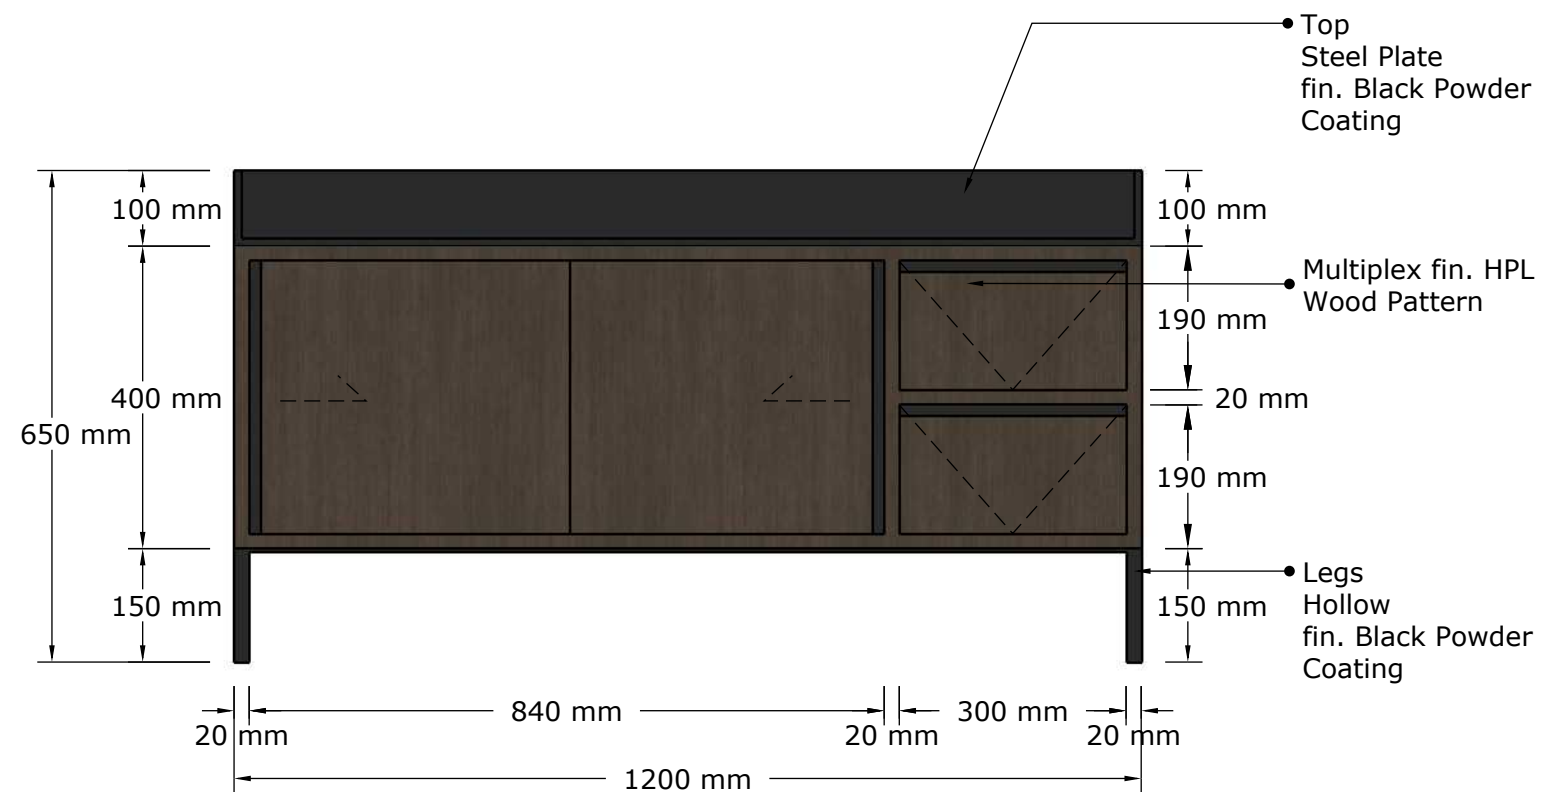


FRONT ELEVATION
SCALE 1:10

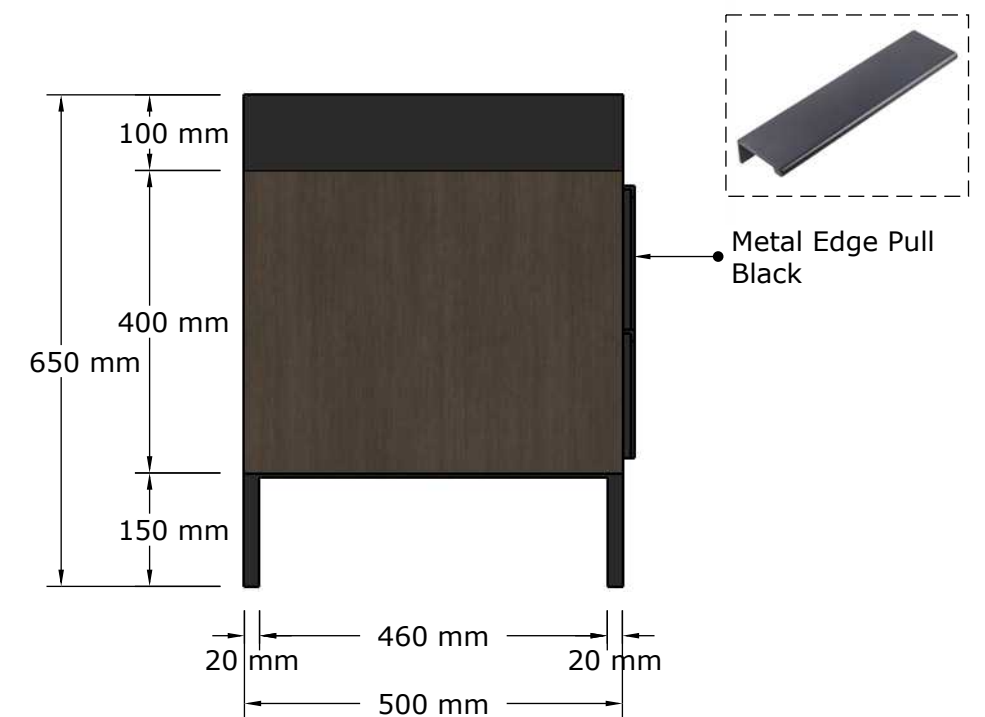

LEFT ELEVATION
SCALE 1:10

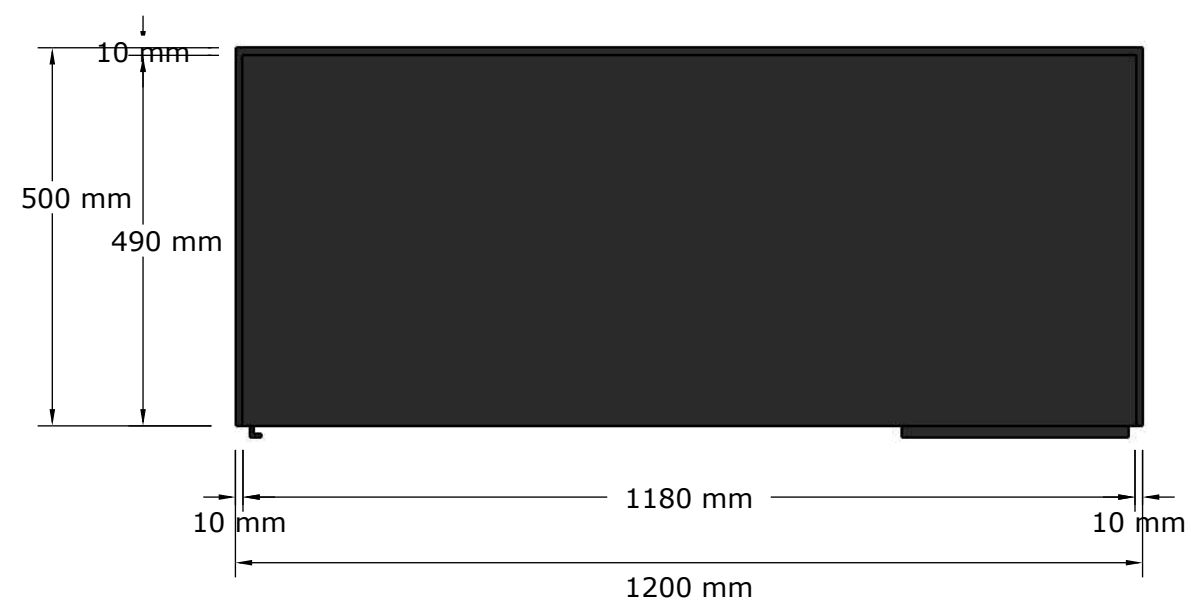

TOP VIEW
SCALE 1:10

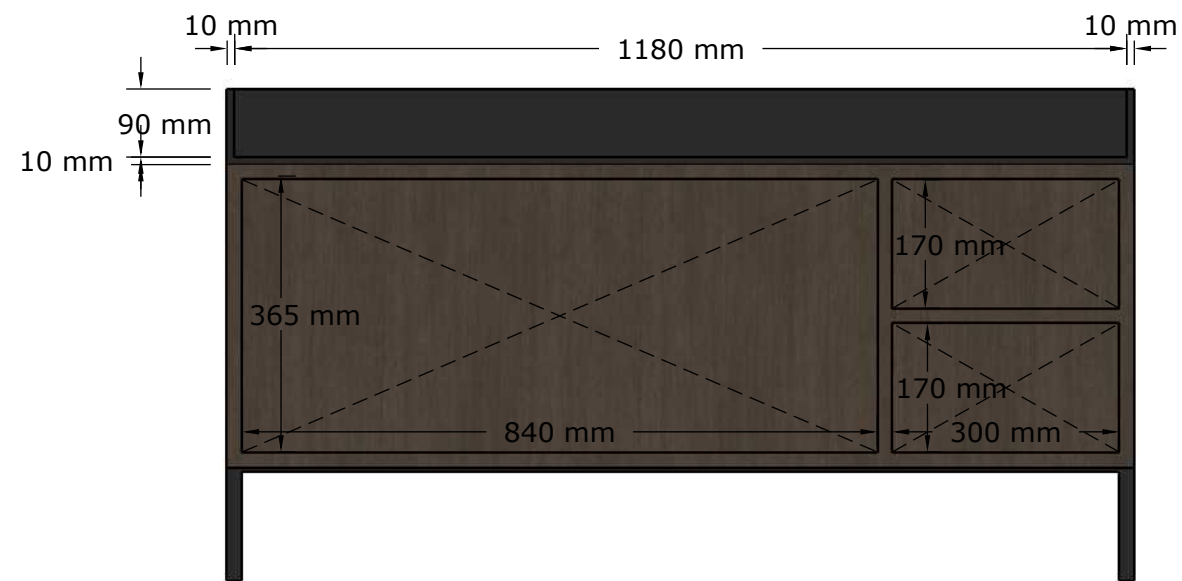


DETAIL
SCALE 1:10




PERSPECTIVE
SCALE NTS

CR-01
DIRECTOR TABLE'S CREDENZA

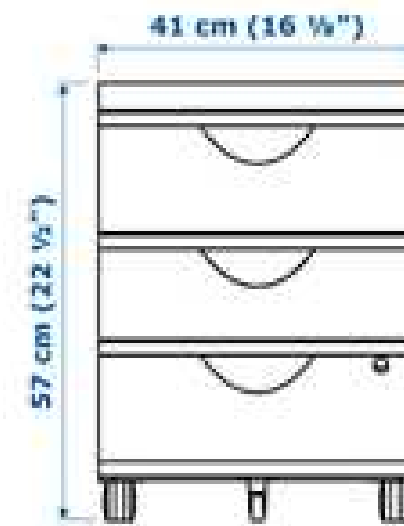


FRONT ELEVATION
SCALE NTS

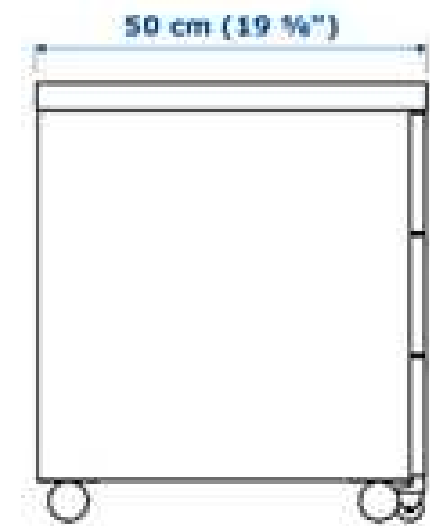


SIDE ELEVATION
SCALE NTS

Note:
Drawer unit w 3 drawers on castors, Ikea Bekant or equivalent

CR-02
WORKSTATION CREDENZA

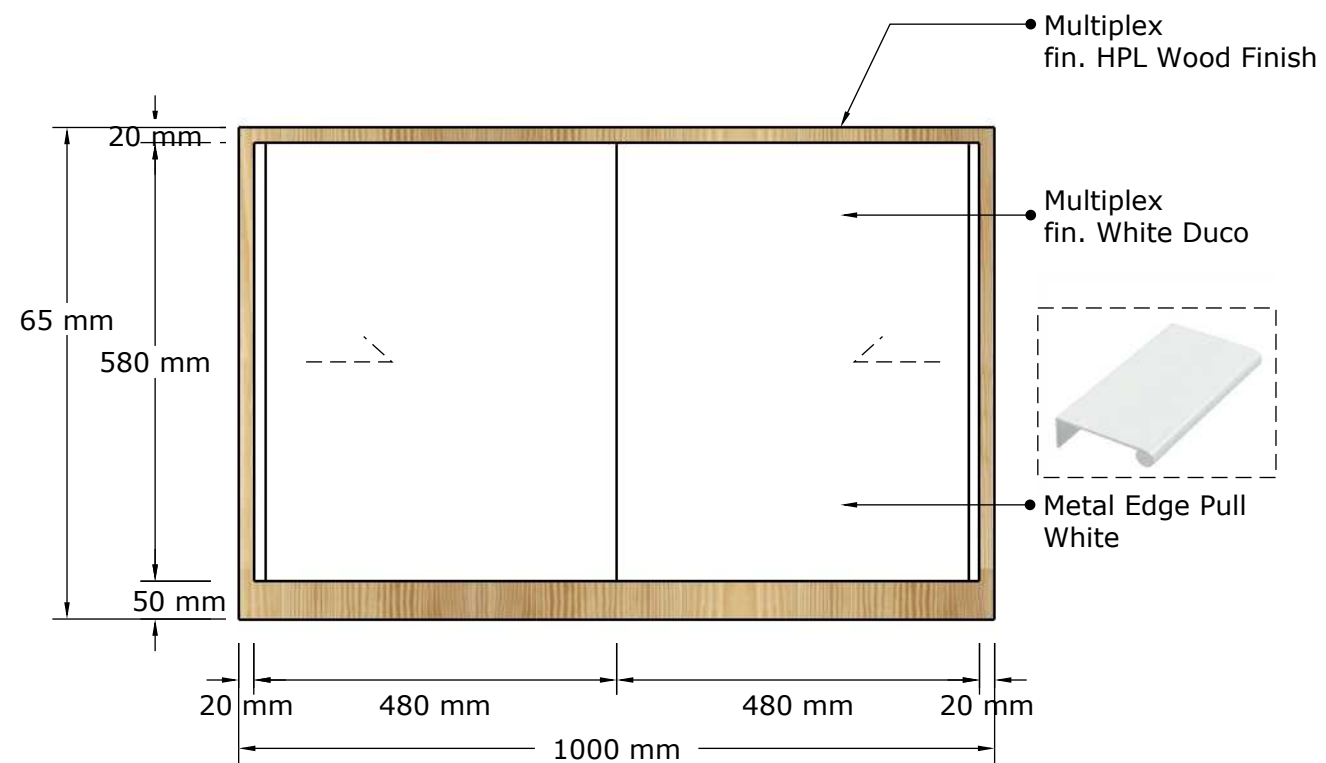


FRONT ELEVATION
SCALE 1:10

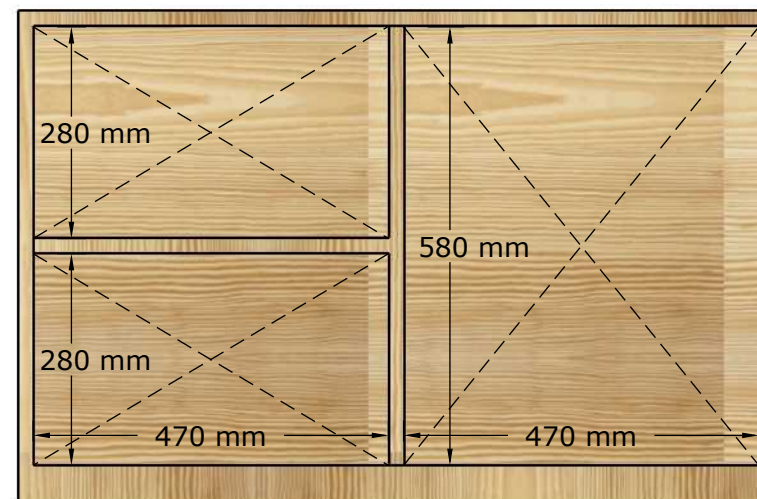


DETAIL
SCALE 1:10




LEFT ELEVATION
SCALE 1:10

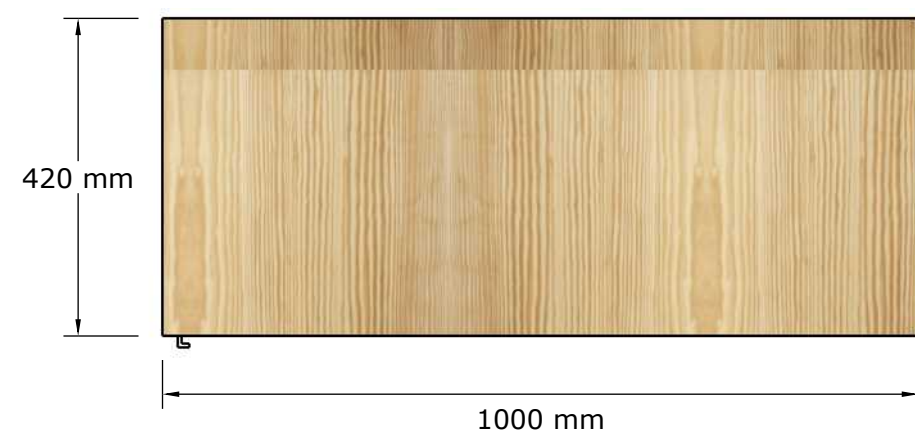


TOP VIEW
SCALE 1:10

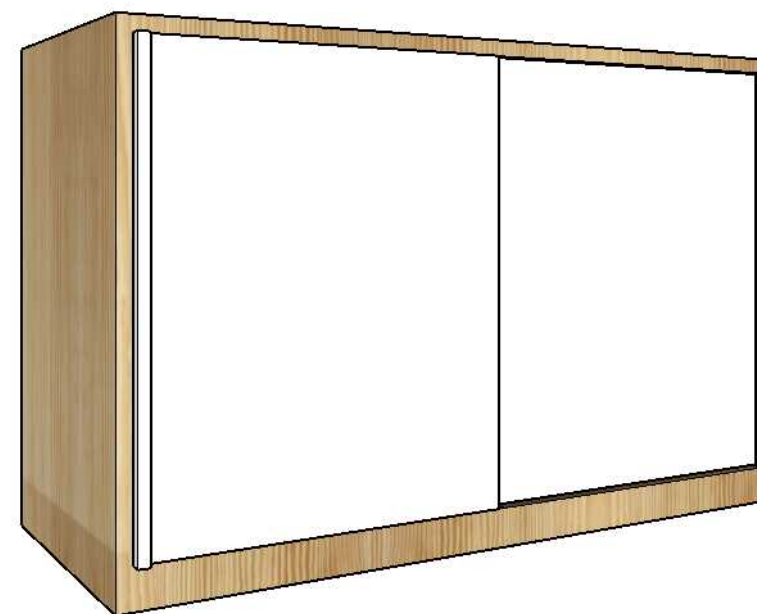


PERSPECTIVE
SCALE NTS

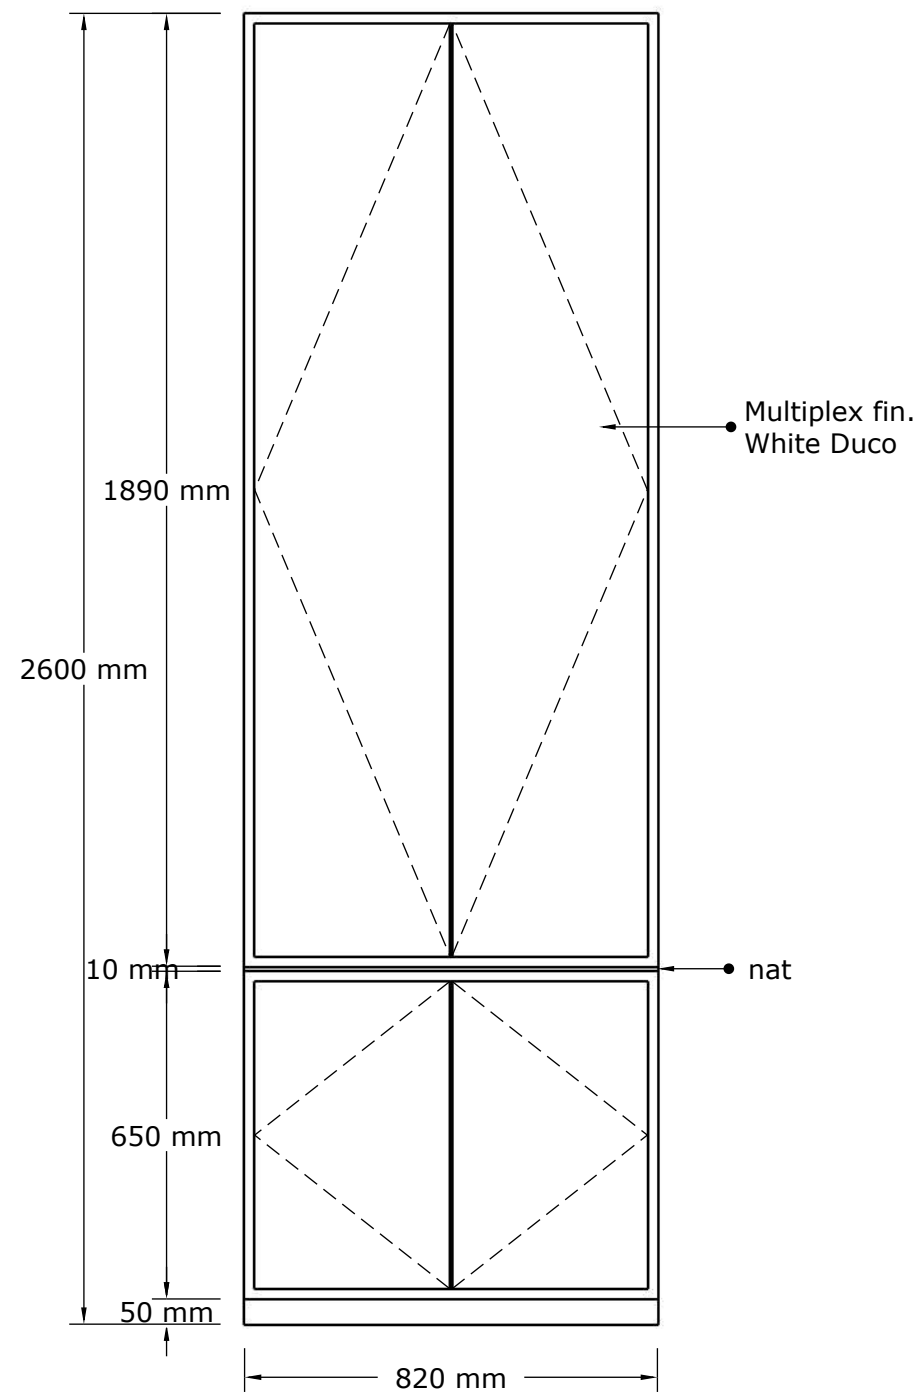


FRONT ELEVATION
SCALE 1:15

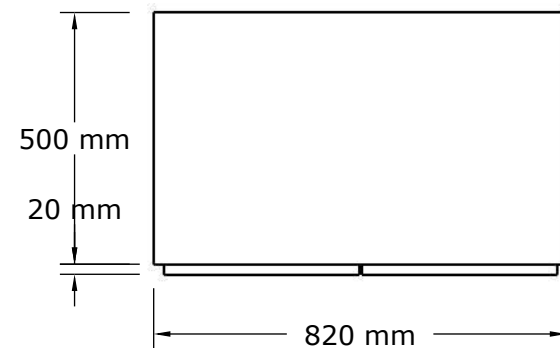


TOP VIEW
SCALE 1:15

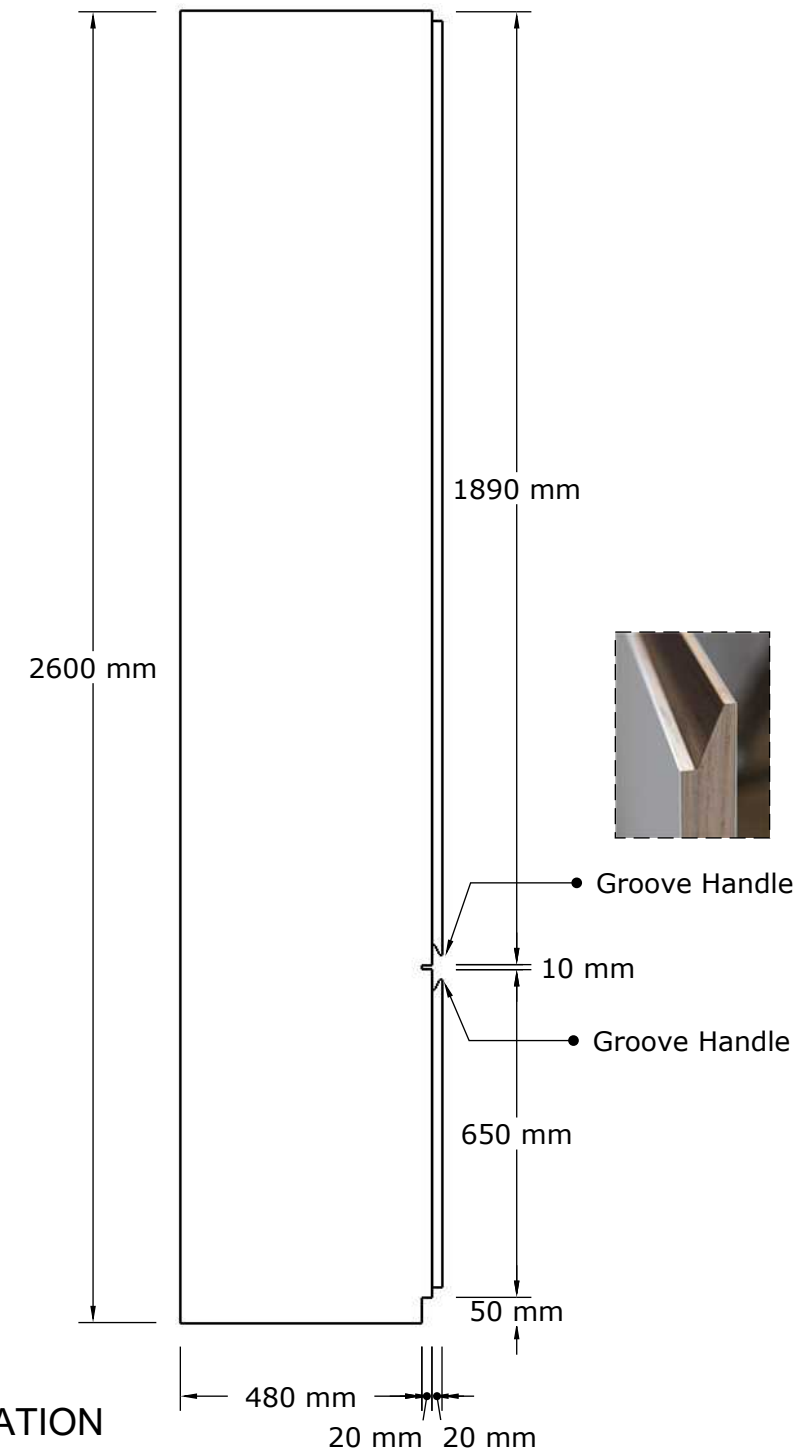

LEFT ELEVATION
SCALE 1:15

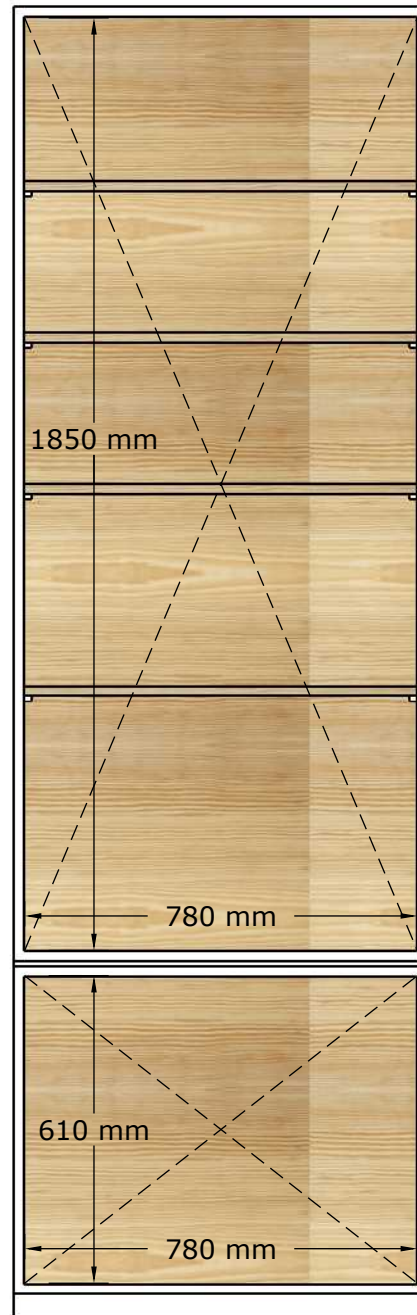

DETAIL
SCALE 1:15

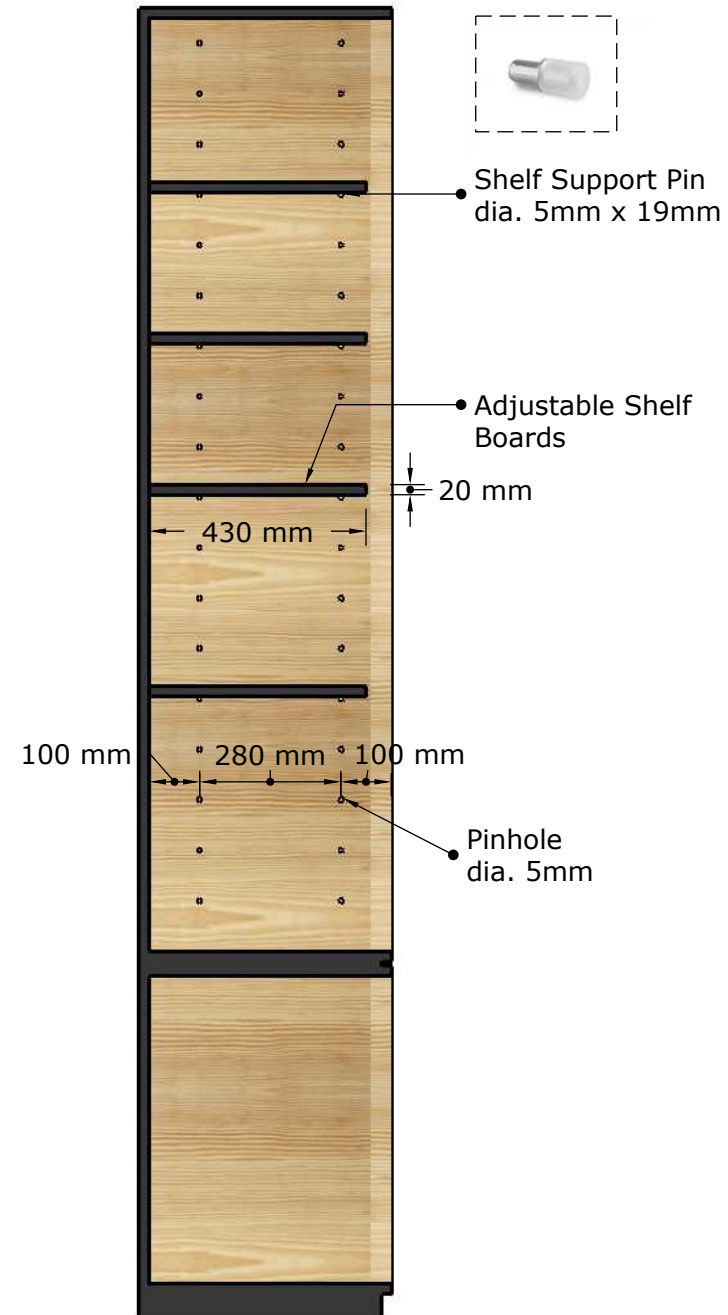


Shelf Support Pin
dia. 5mm x 19mm


Adjustable Shelf
Boards

20 mm


Pinhole
dia. 5mm

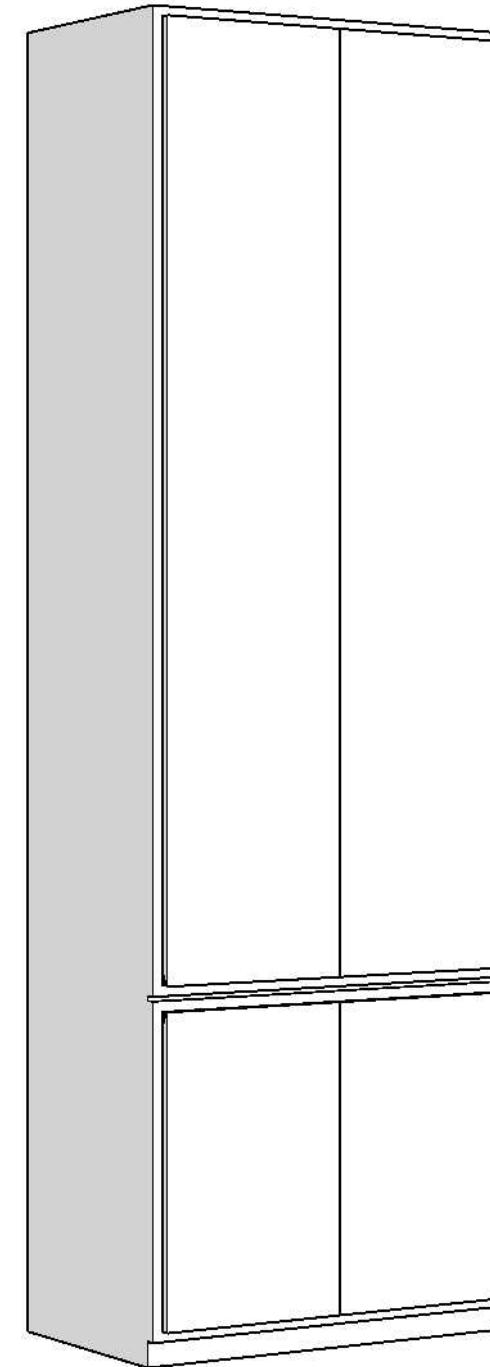


PERSPECTIVE
SCALE NTS

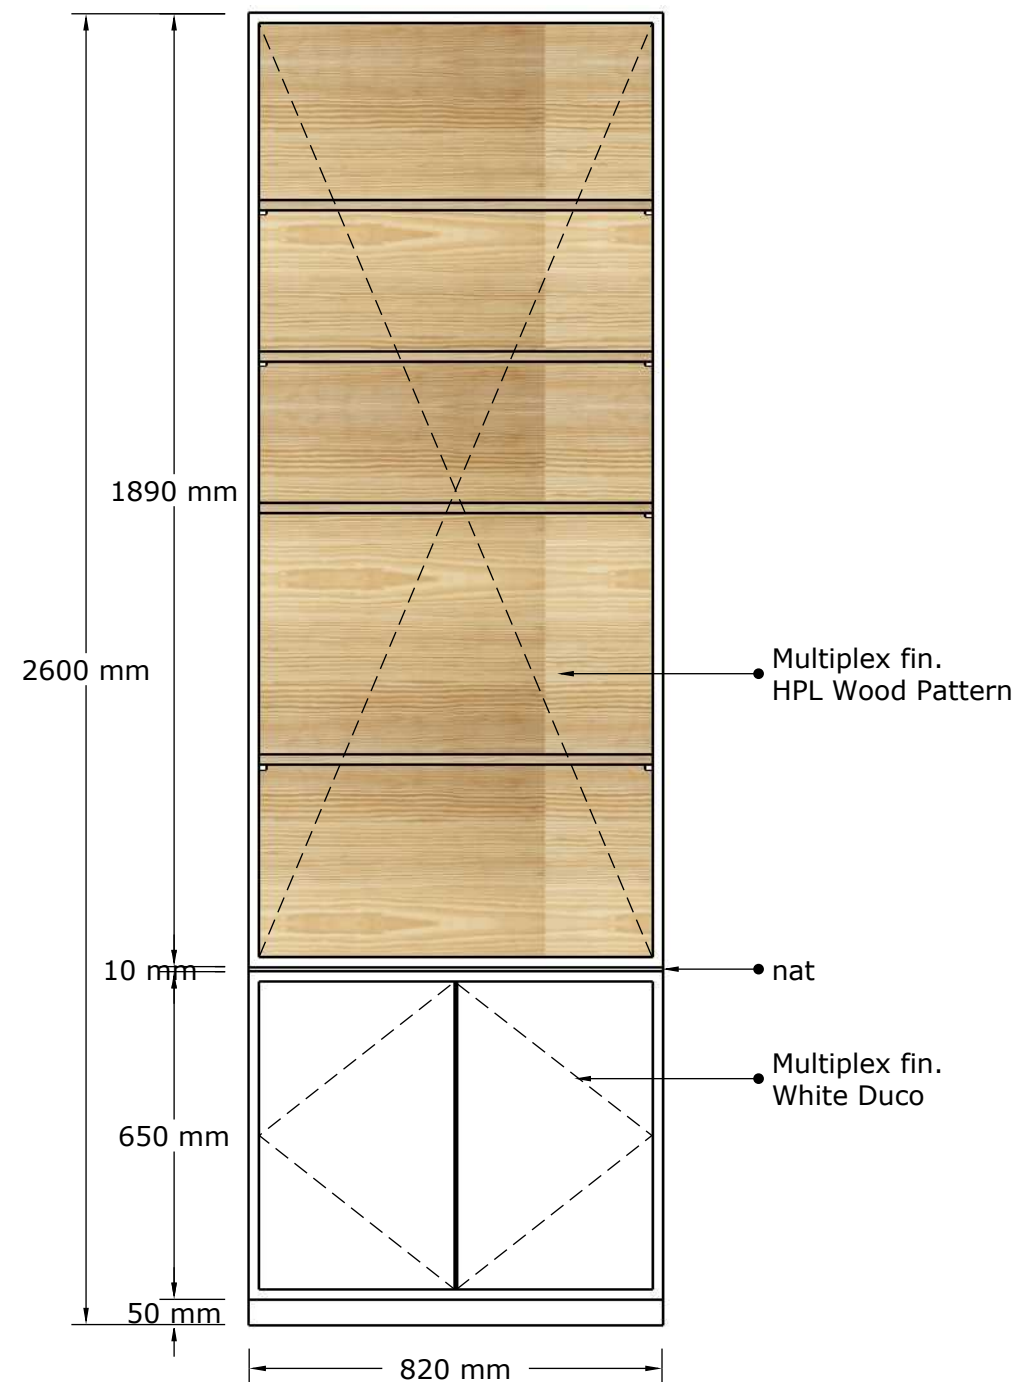


FRONT ELEVATION
SCALE 1:15

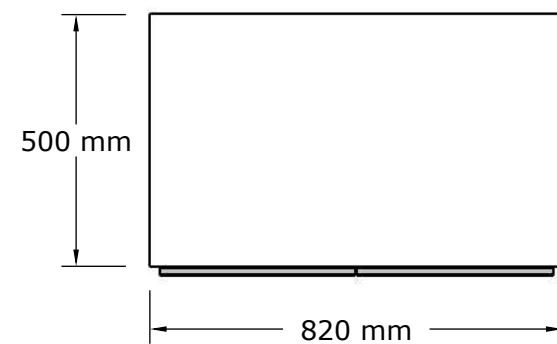


TOP VIEW
SCALE 1:15

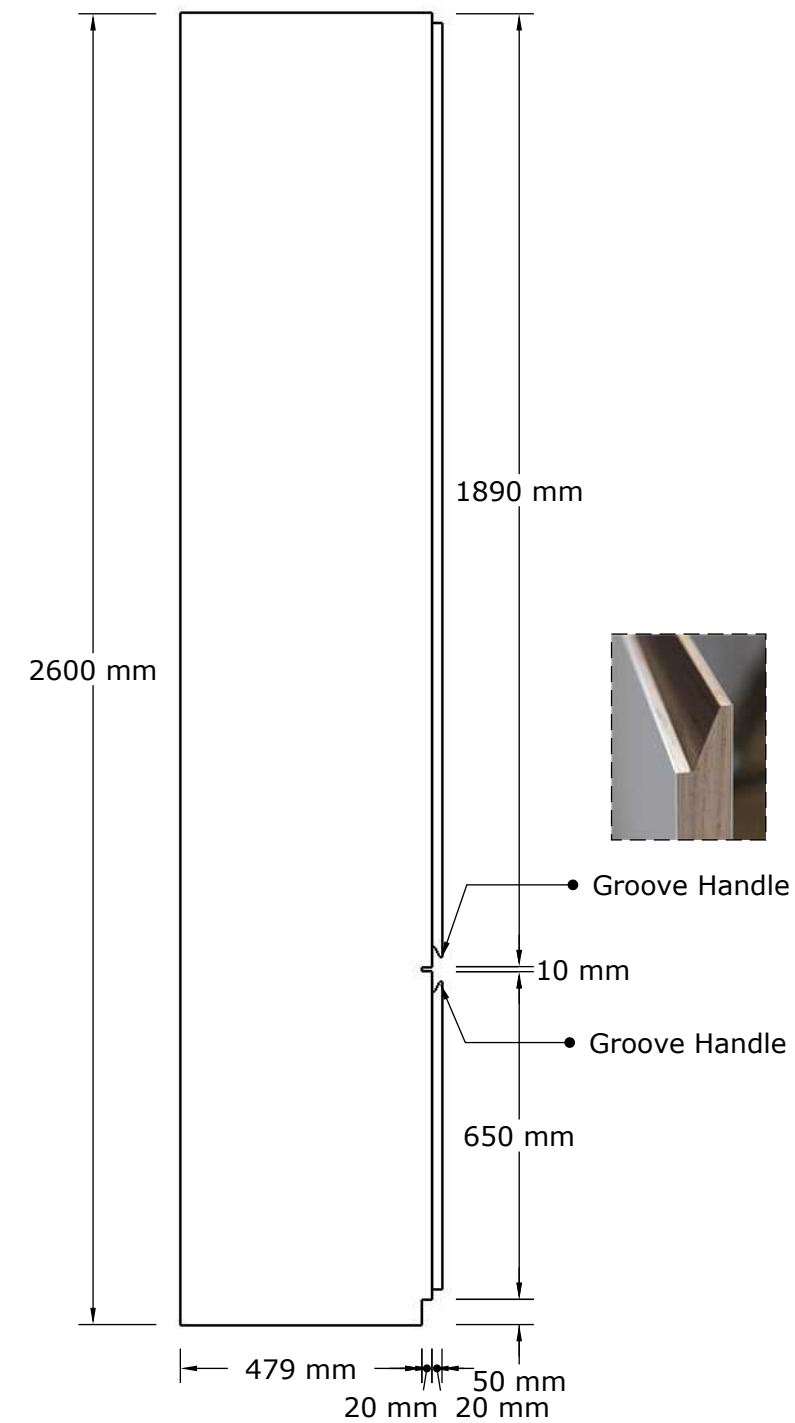

LEFT ELEVATION
SCALE 1:15

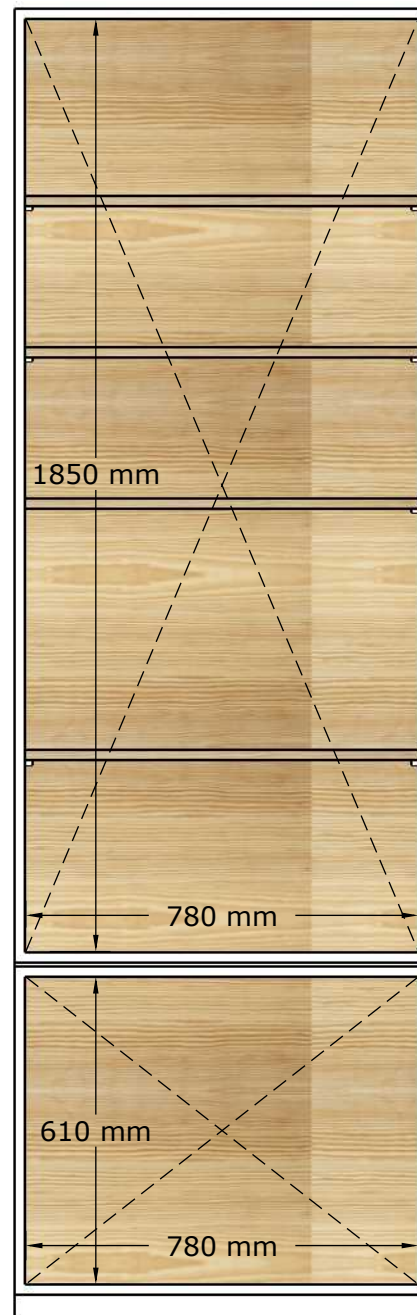


DETAIL
SCALE 1:15

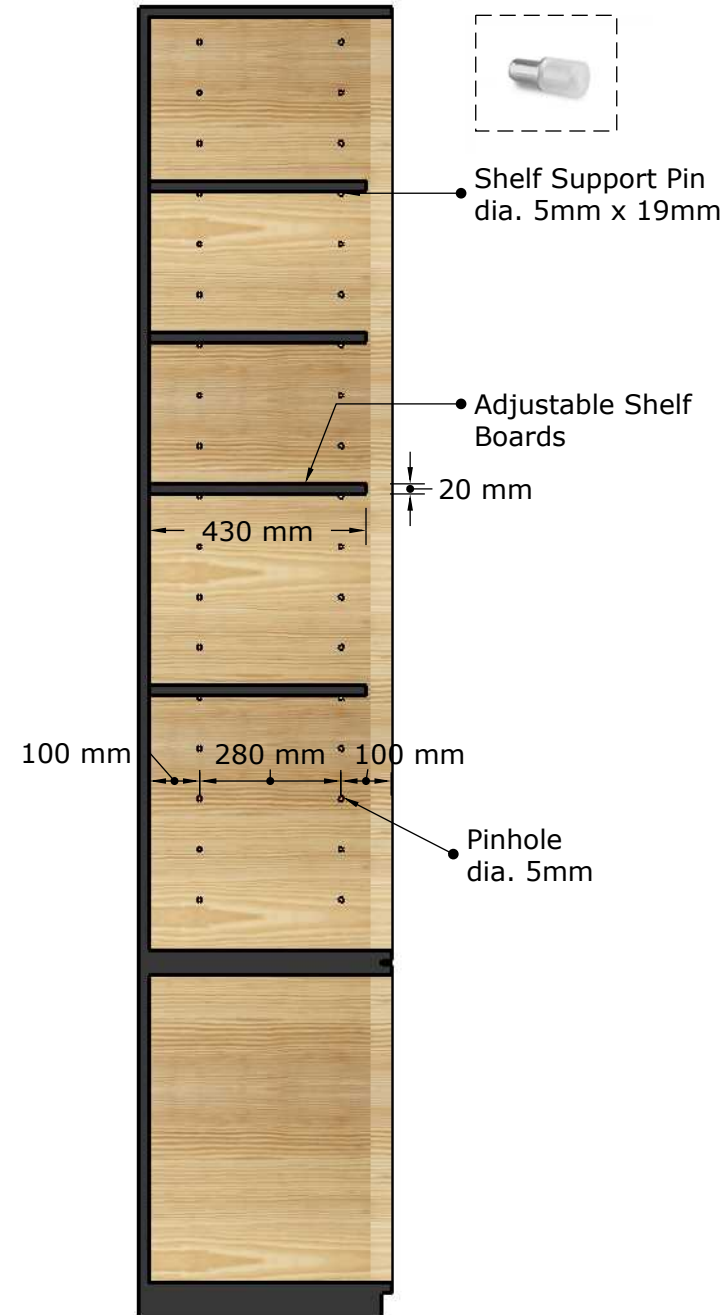

PERSPECTIVE
SCALE NTS




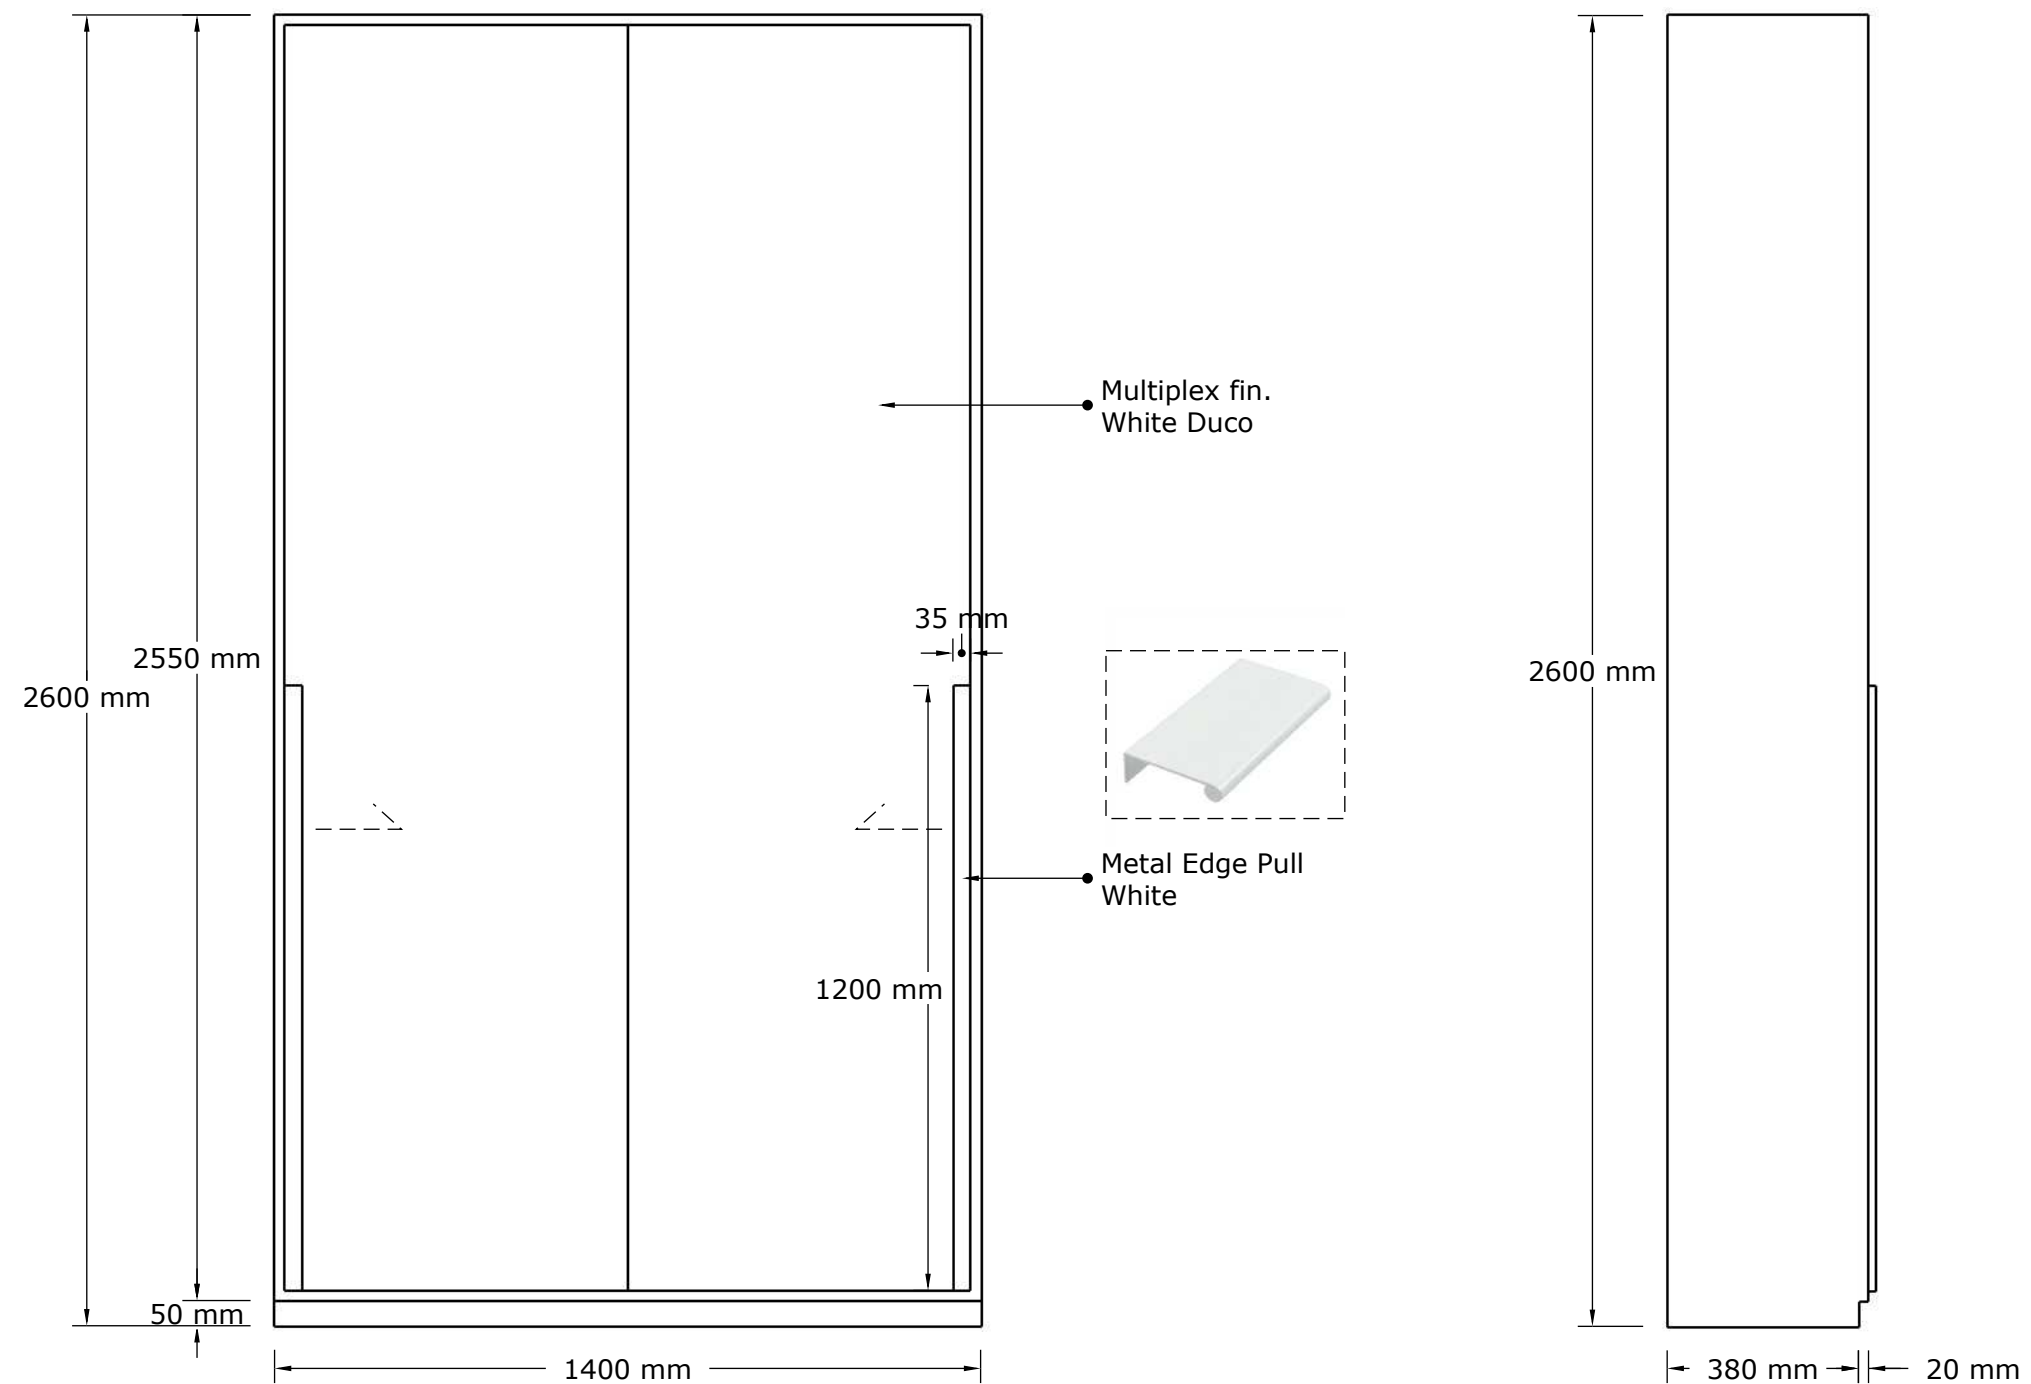


FRONT ELEVATION
SCALE 1:15

LEFT ELEVATION
SCALE 1:15

TOP VIEW
SCALE 1:15

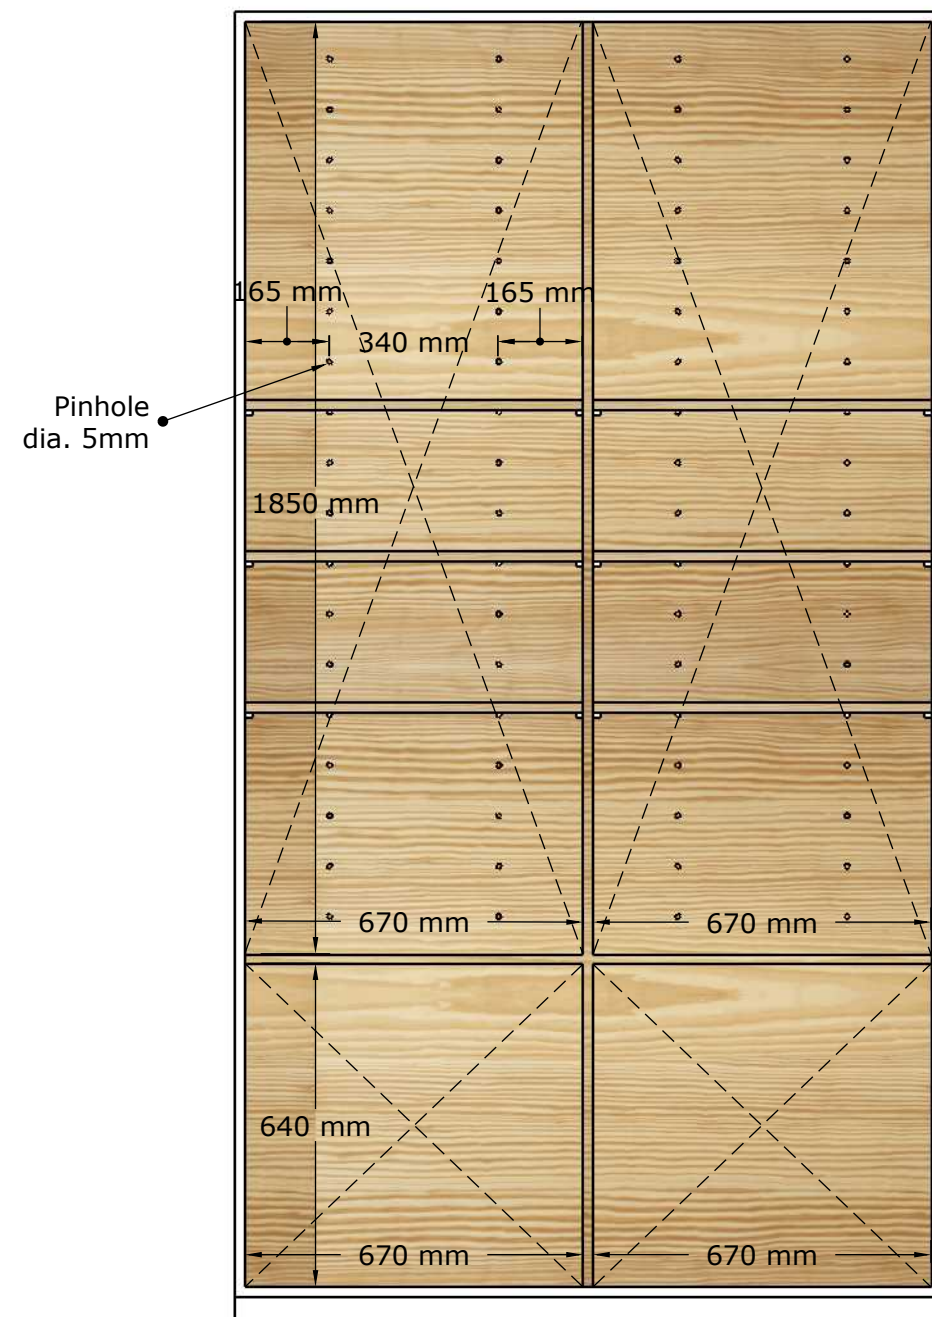


DETAIL
SCALE 1:15

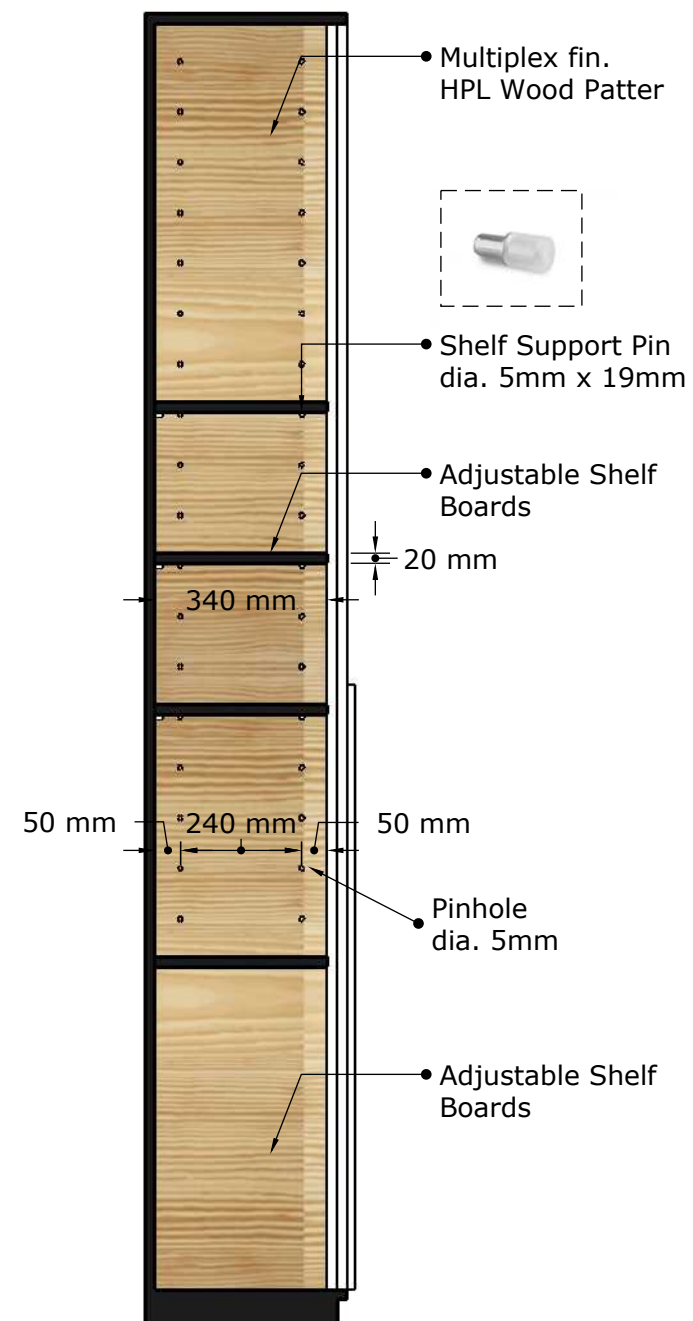


PERSPECTIVE
SCALE NTS




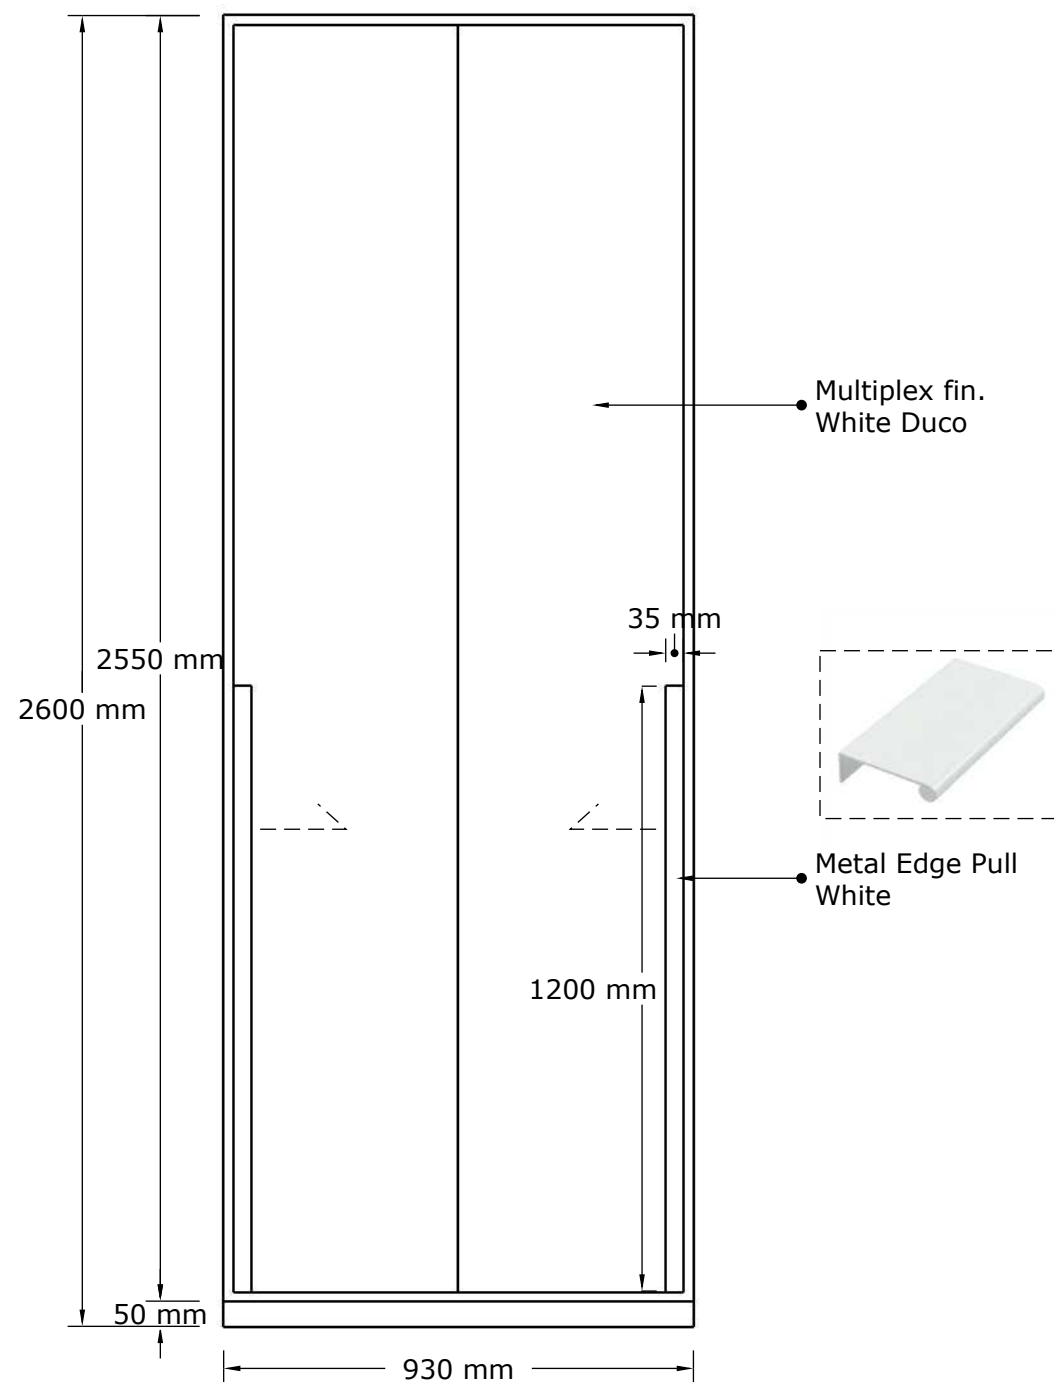


FRONT ELEVATION
SCALE 1:15

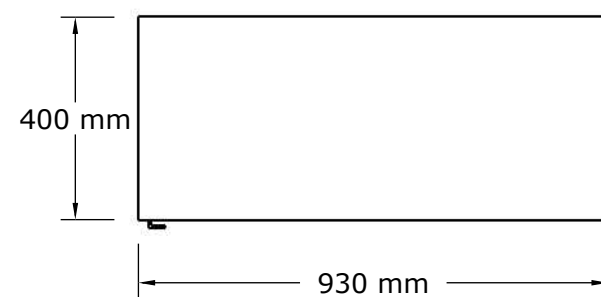


TOP VIEW
SCALE 1:15

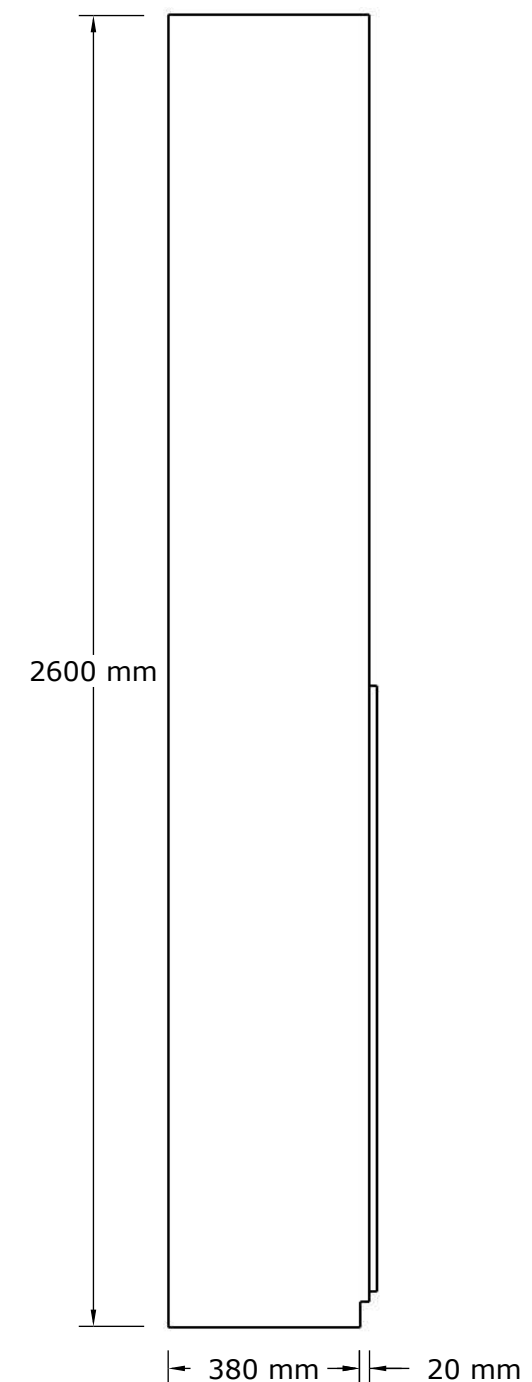


LEFT ELEVATION
SCALE 1:15



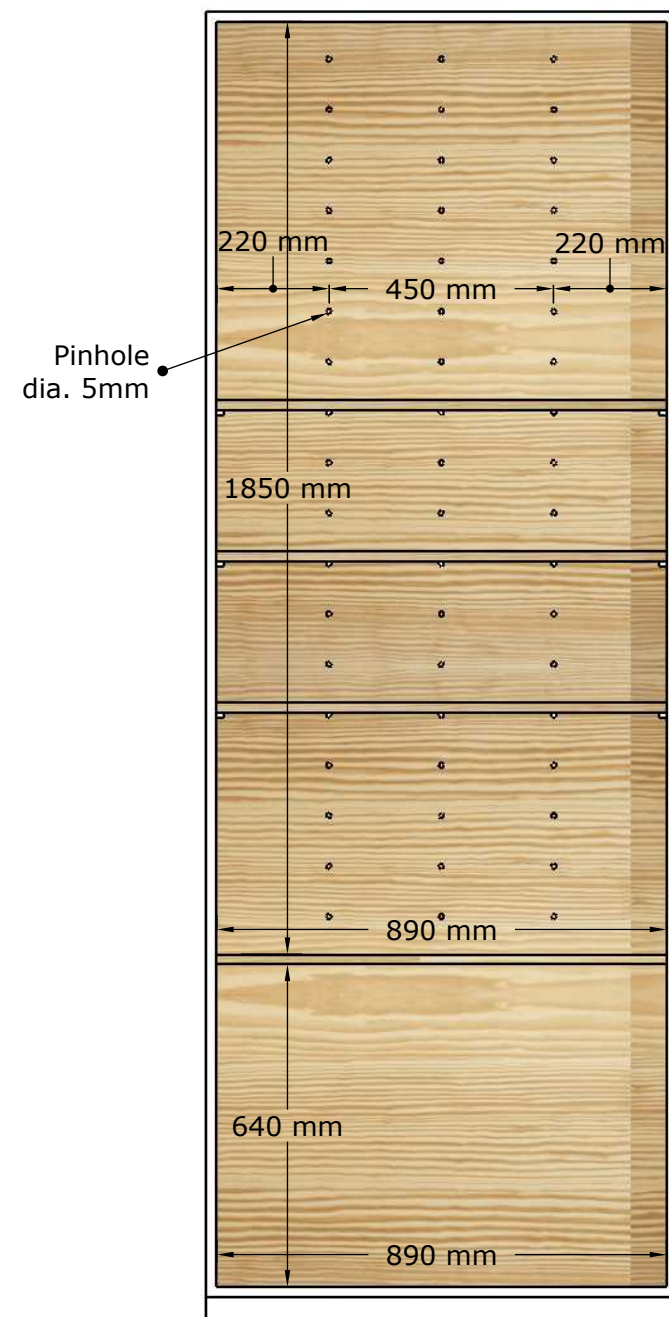



DETAIL
SCALE 1:15

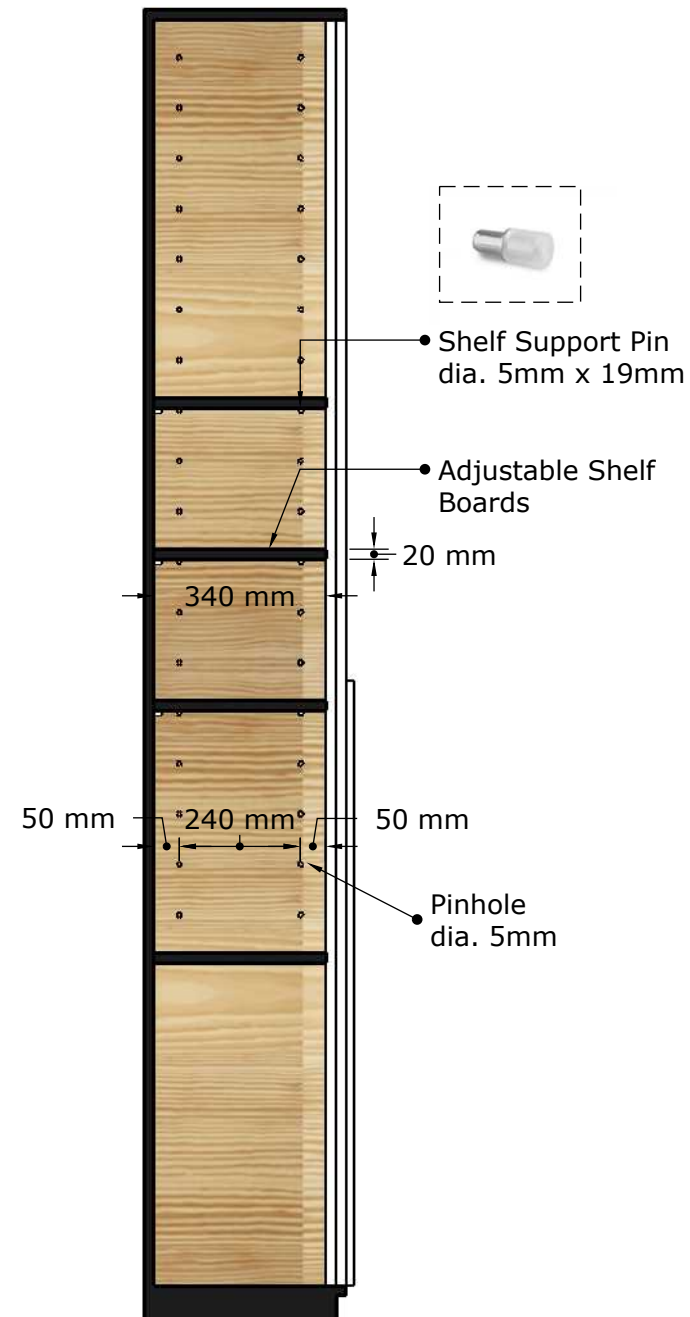

PERSPECTIVE
SCALE NTS

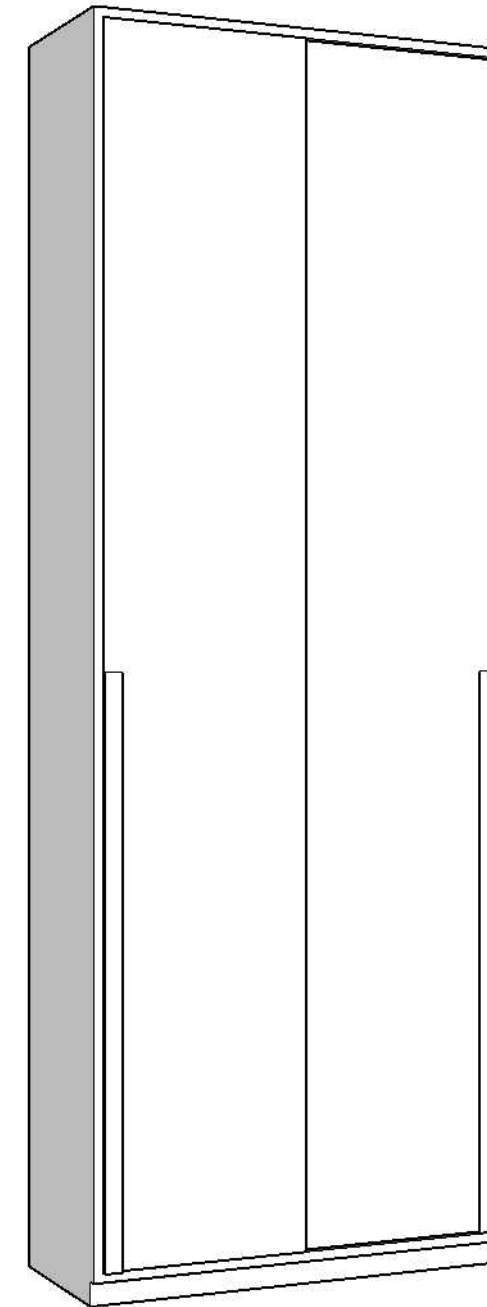

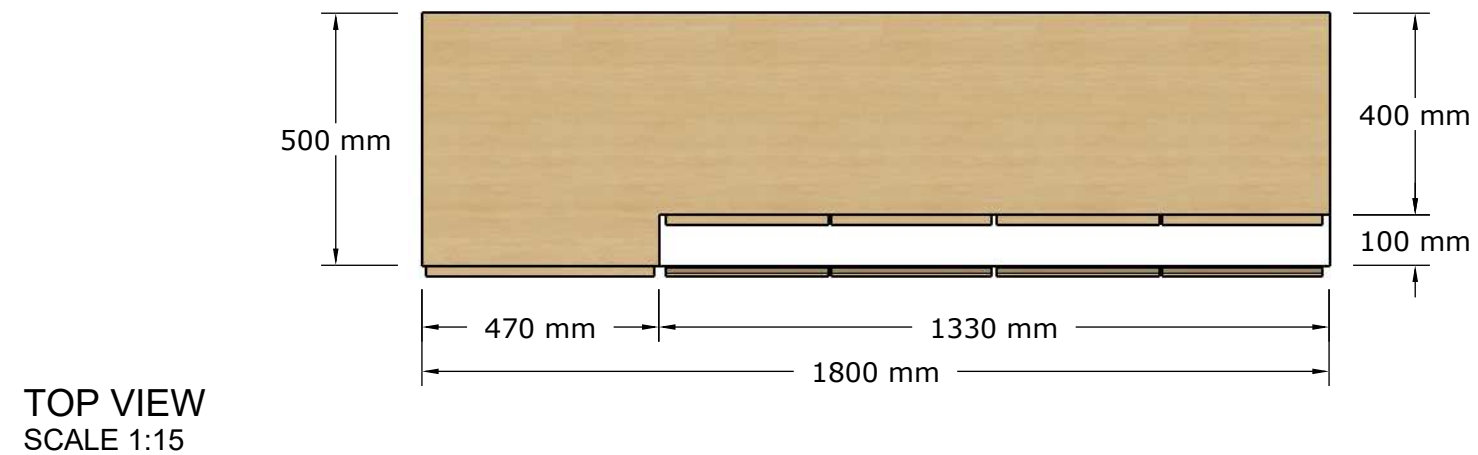
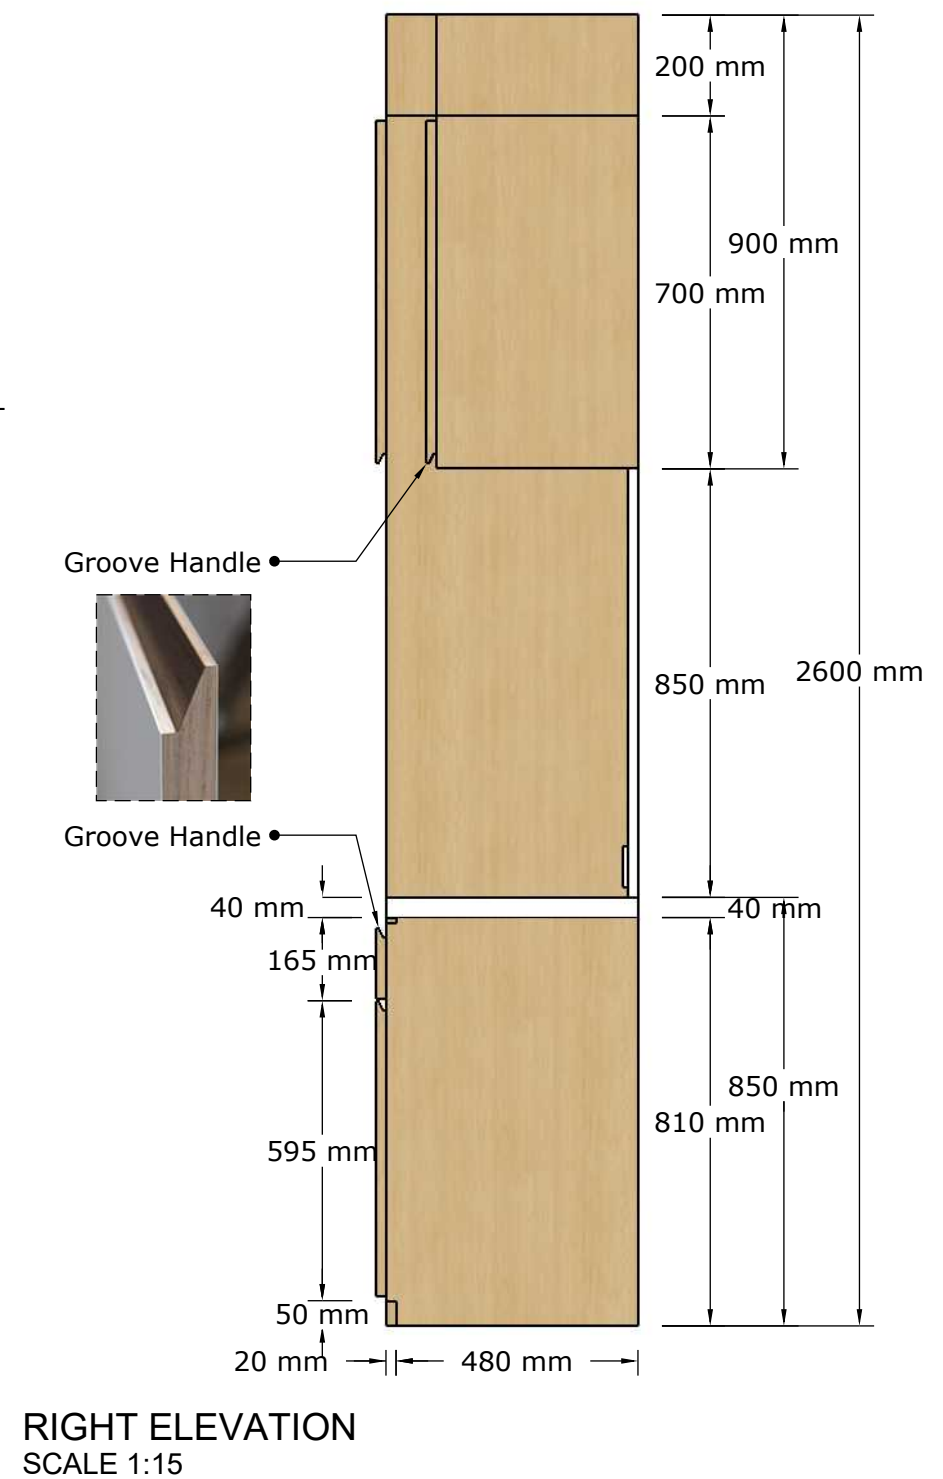
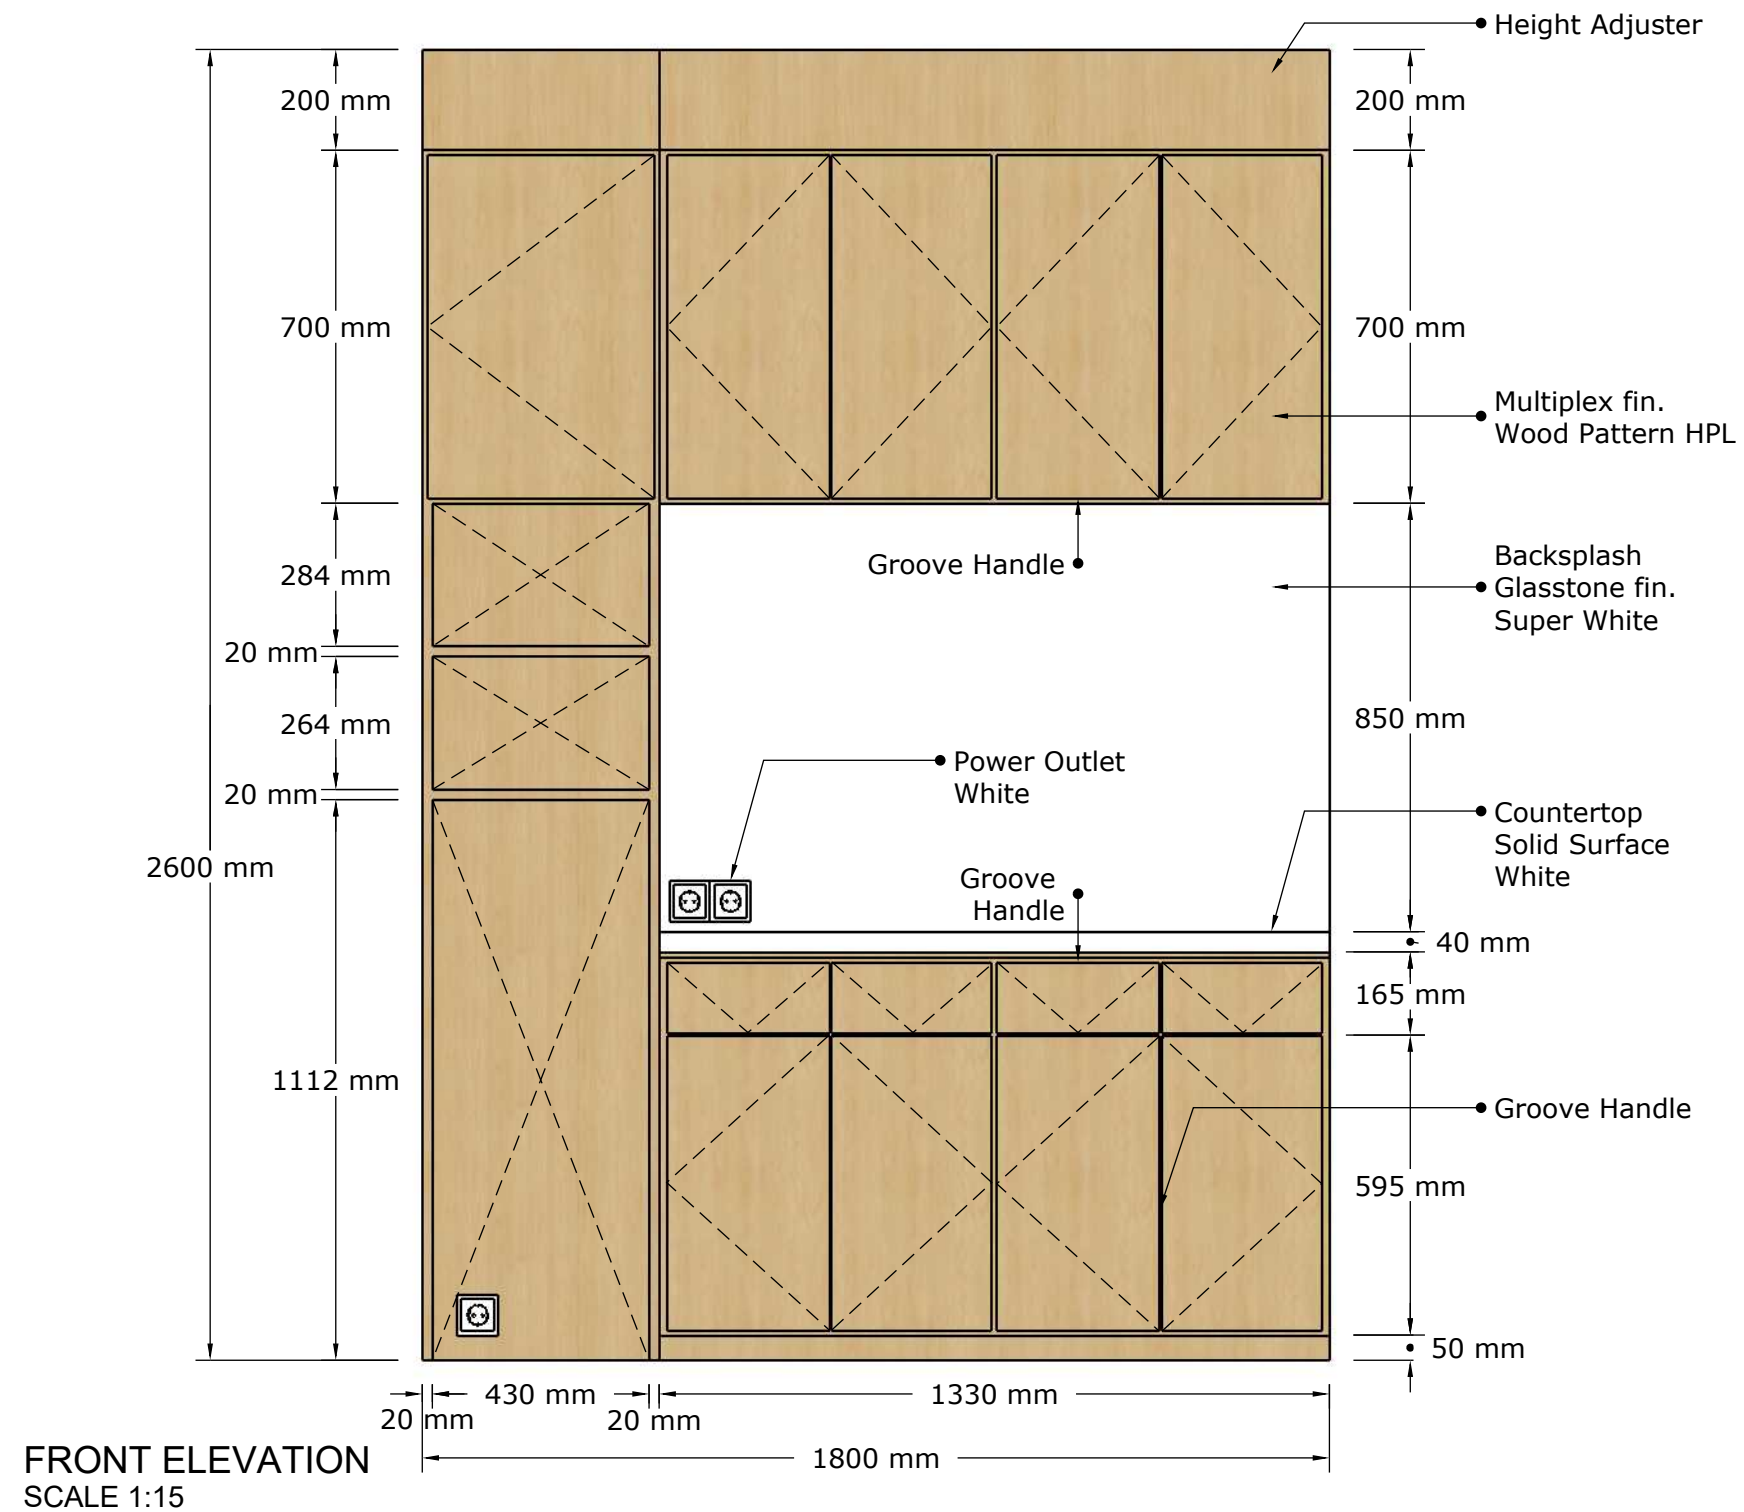


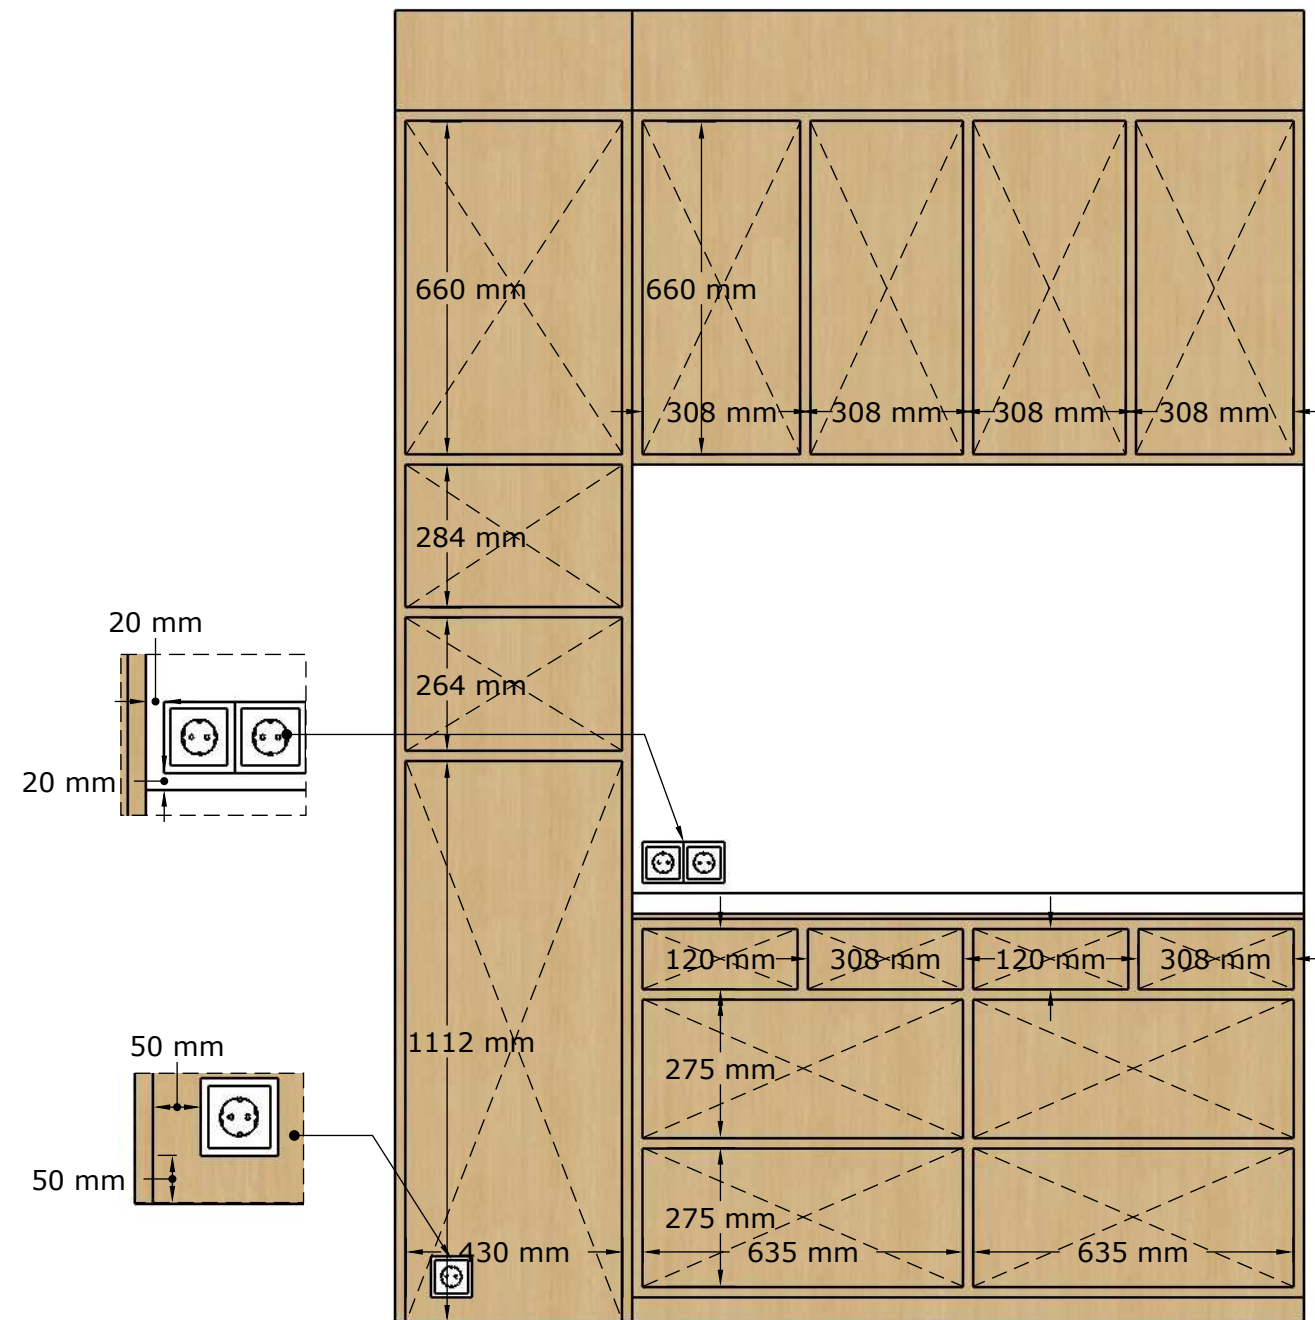


DETAIL
SCALE 1:15




PERSPECTIVE
SCALE NTS

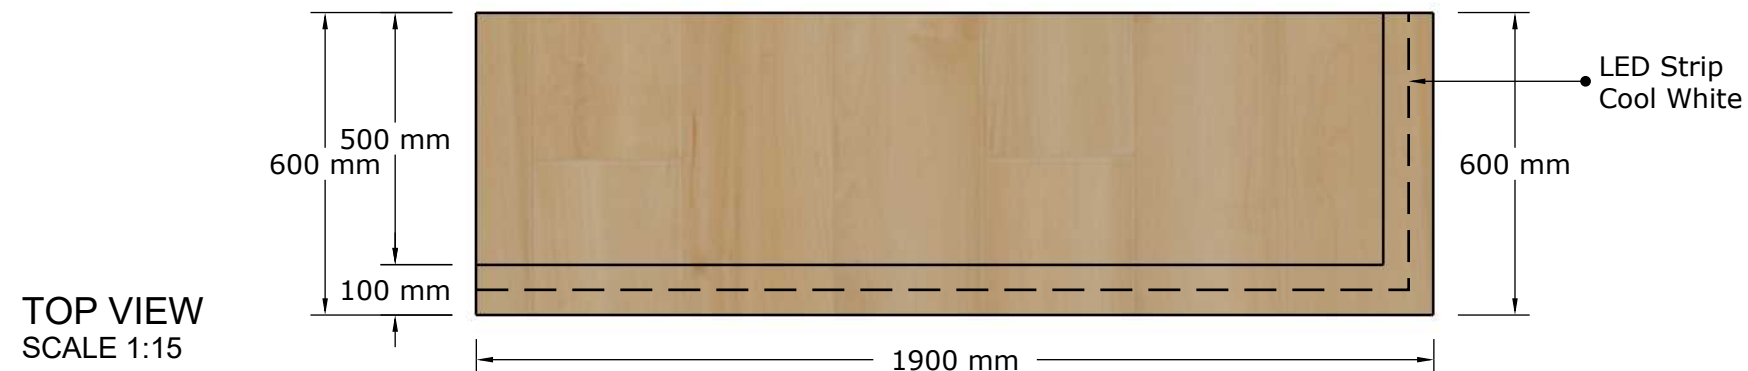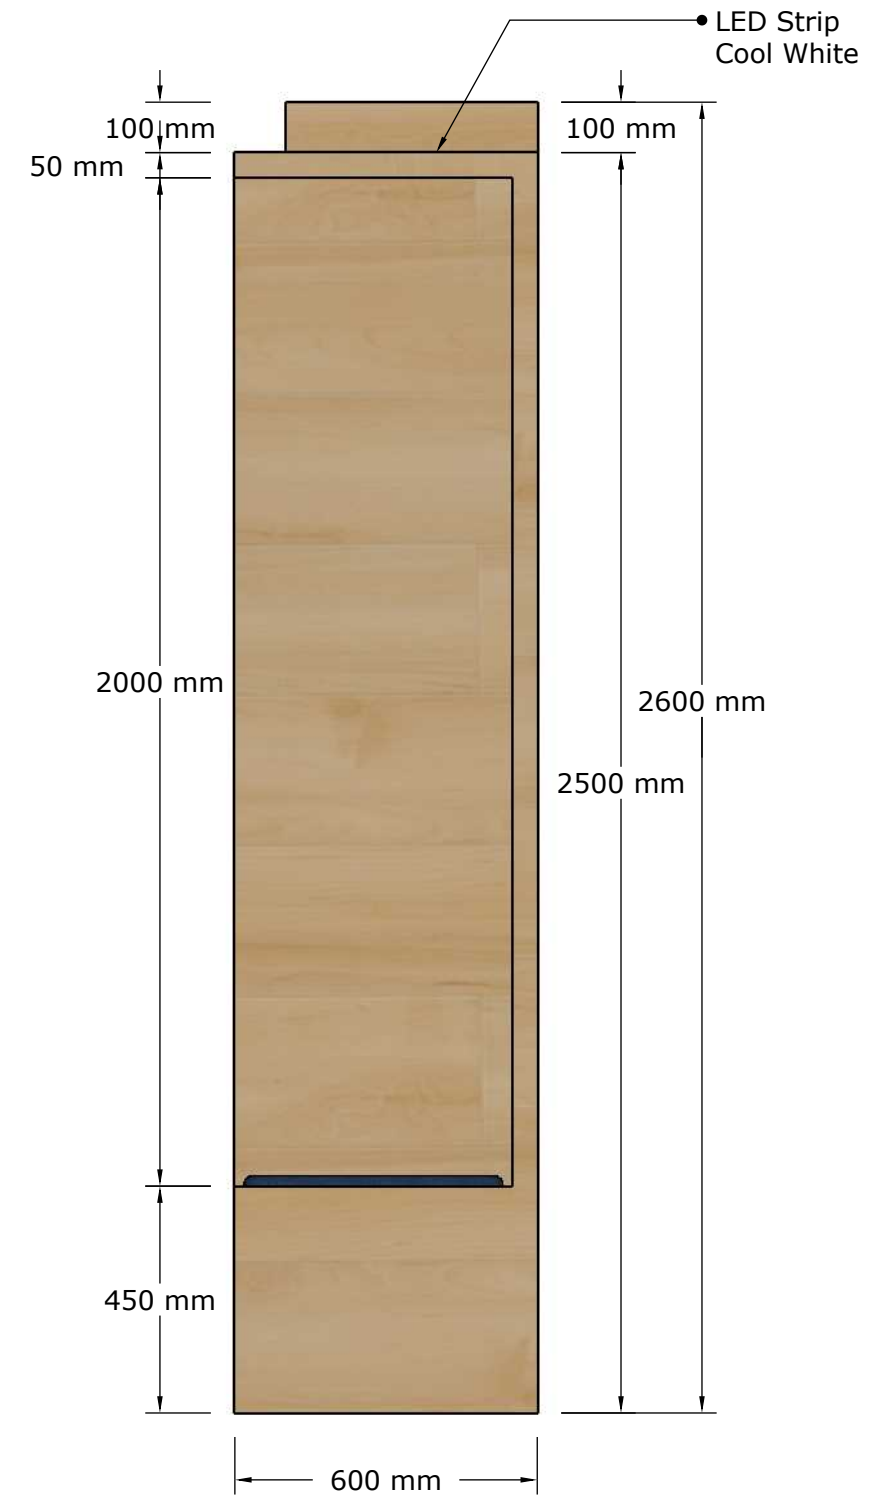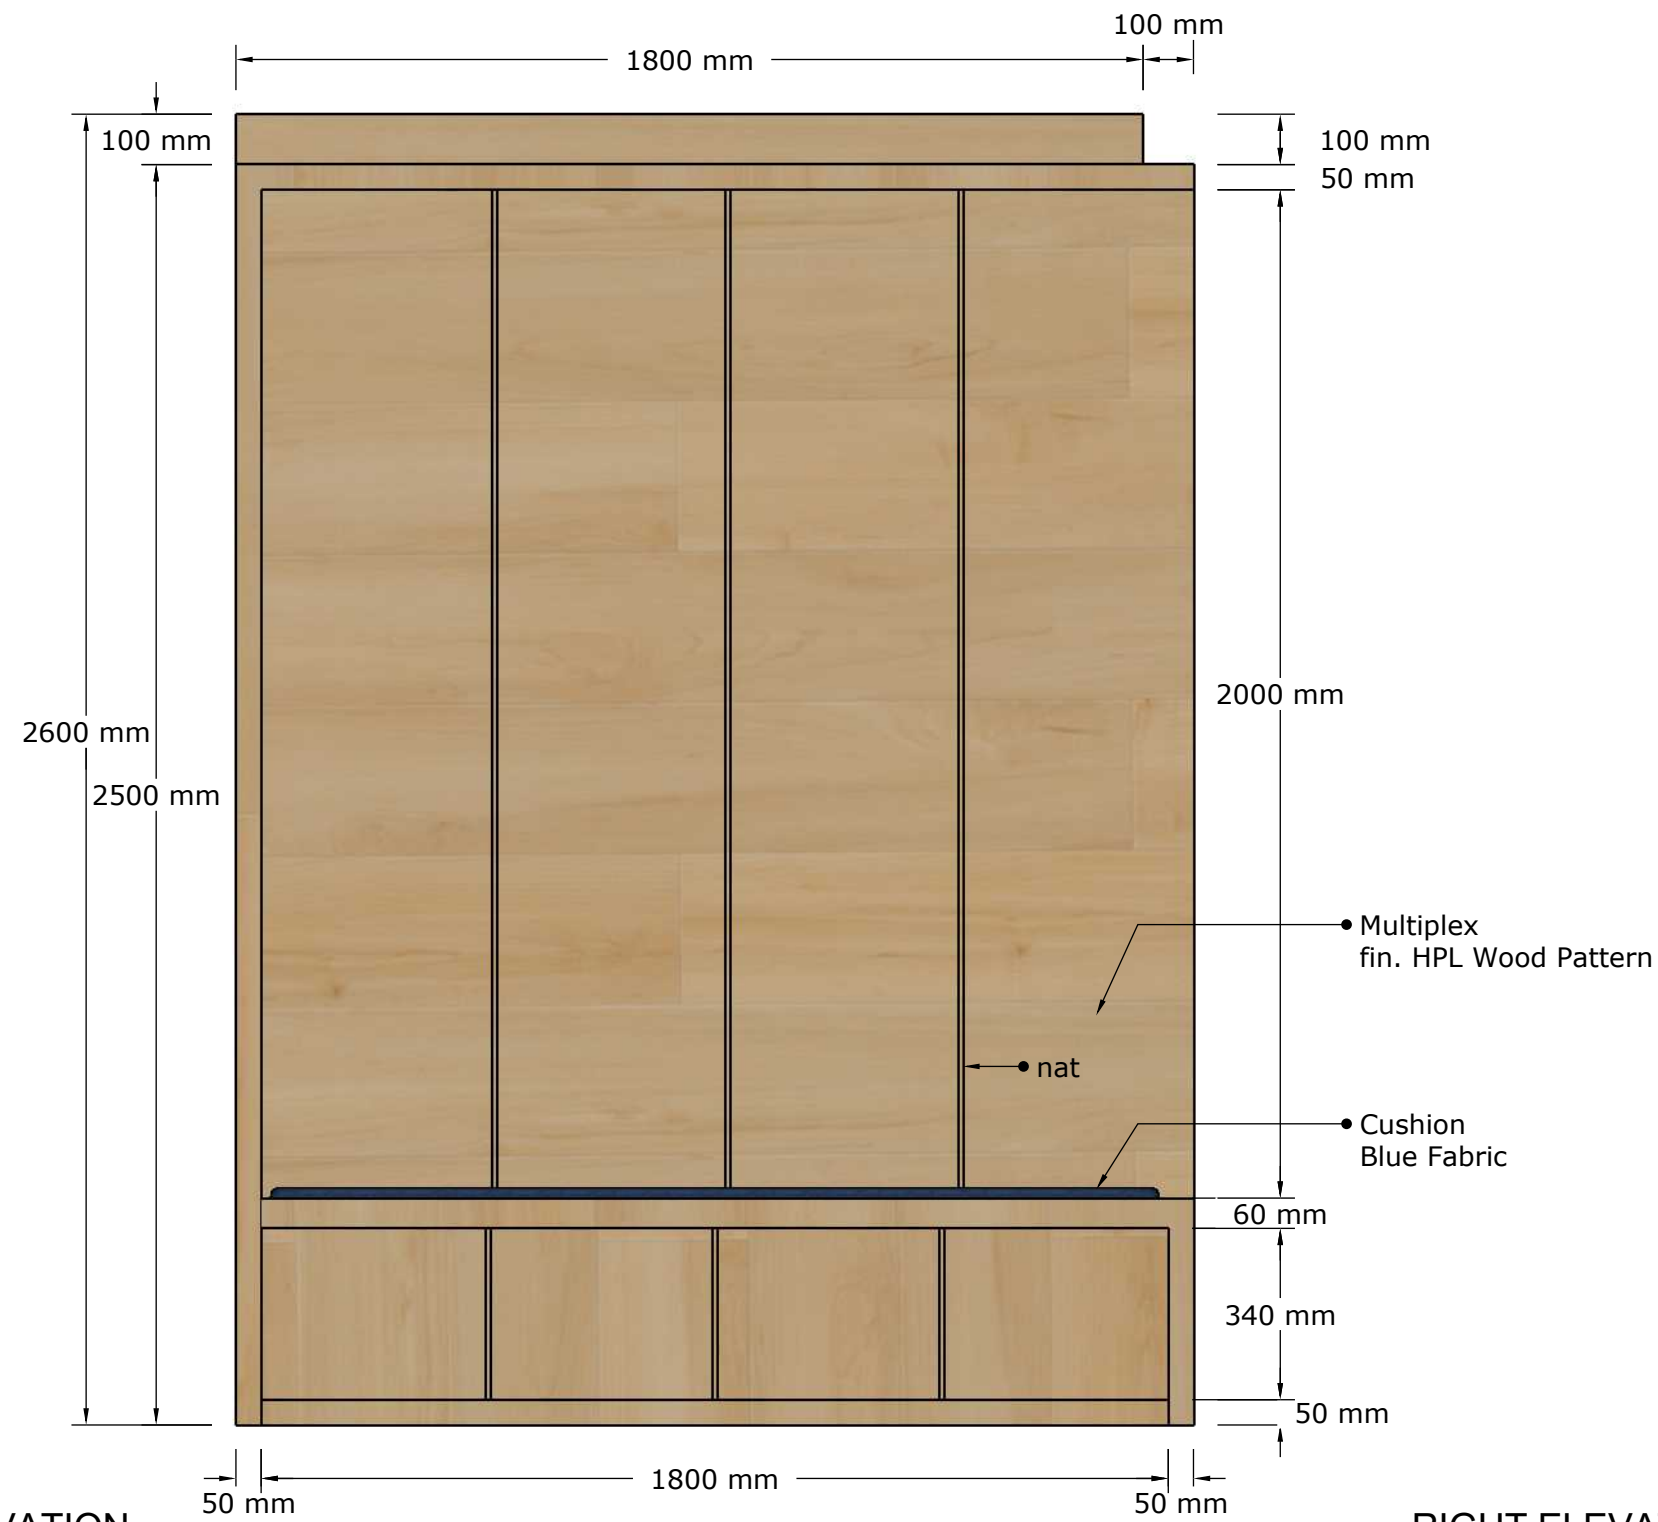


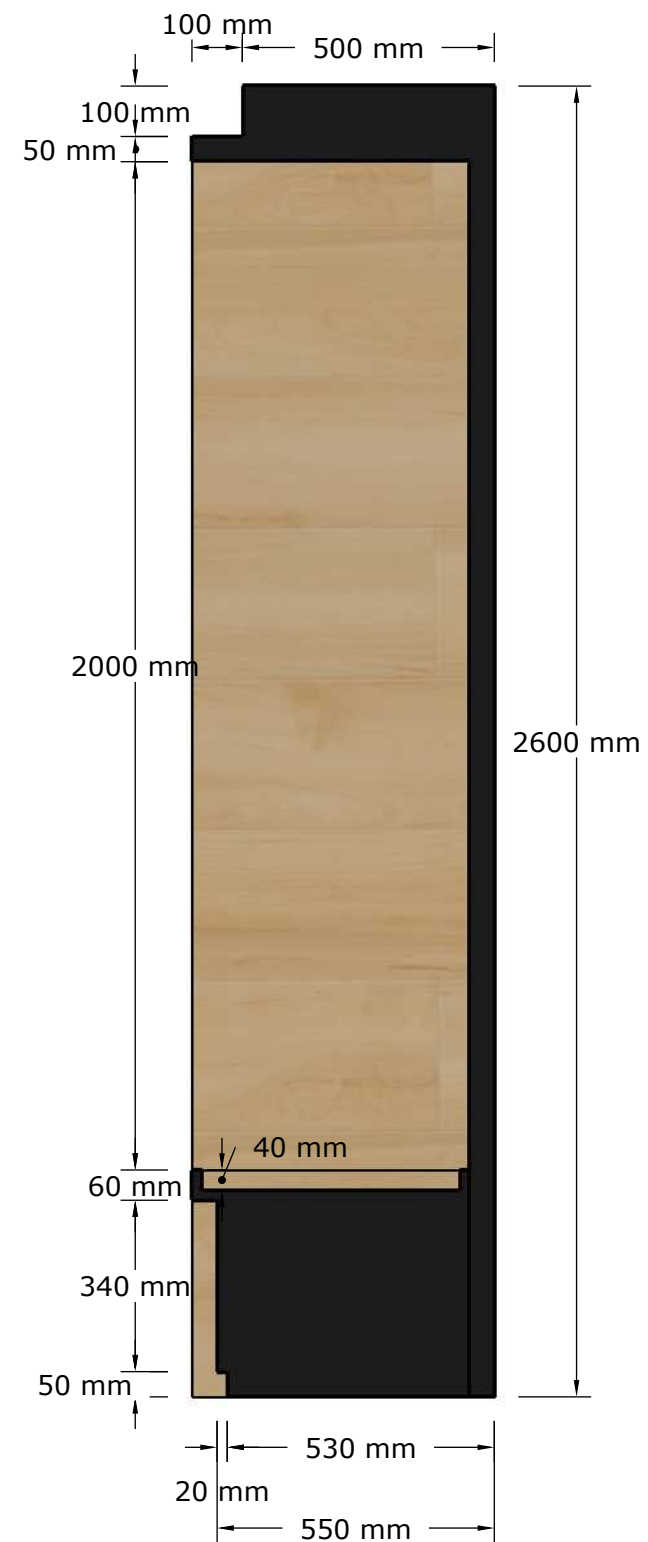


DETAIL
SCALE 1:15

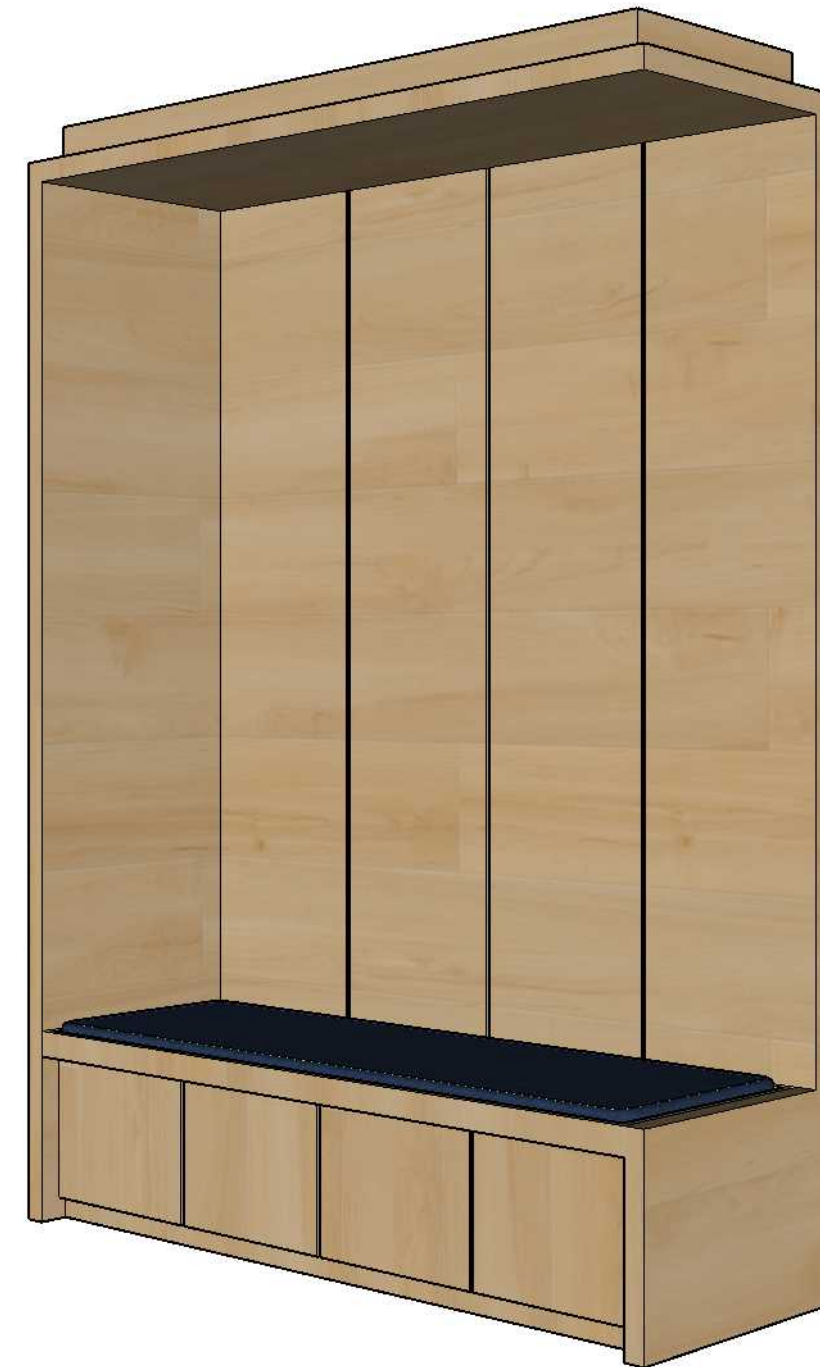

PERSPECTIVE
SCALE NTS

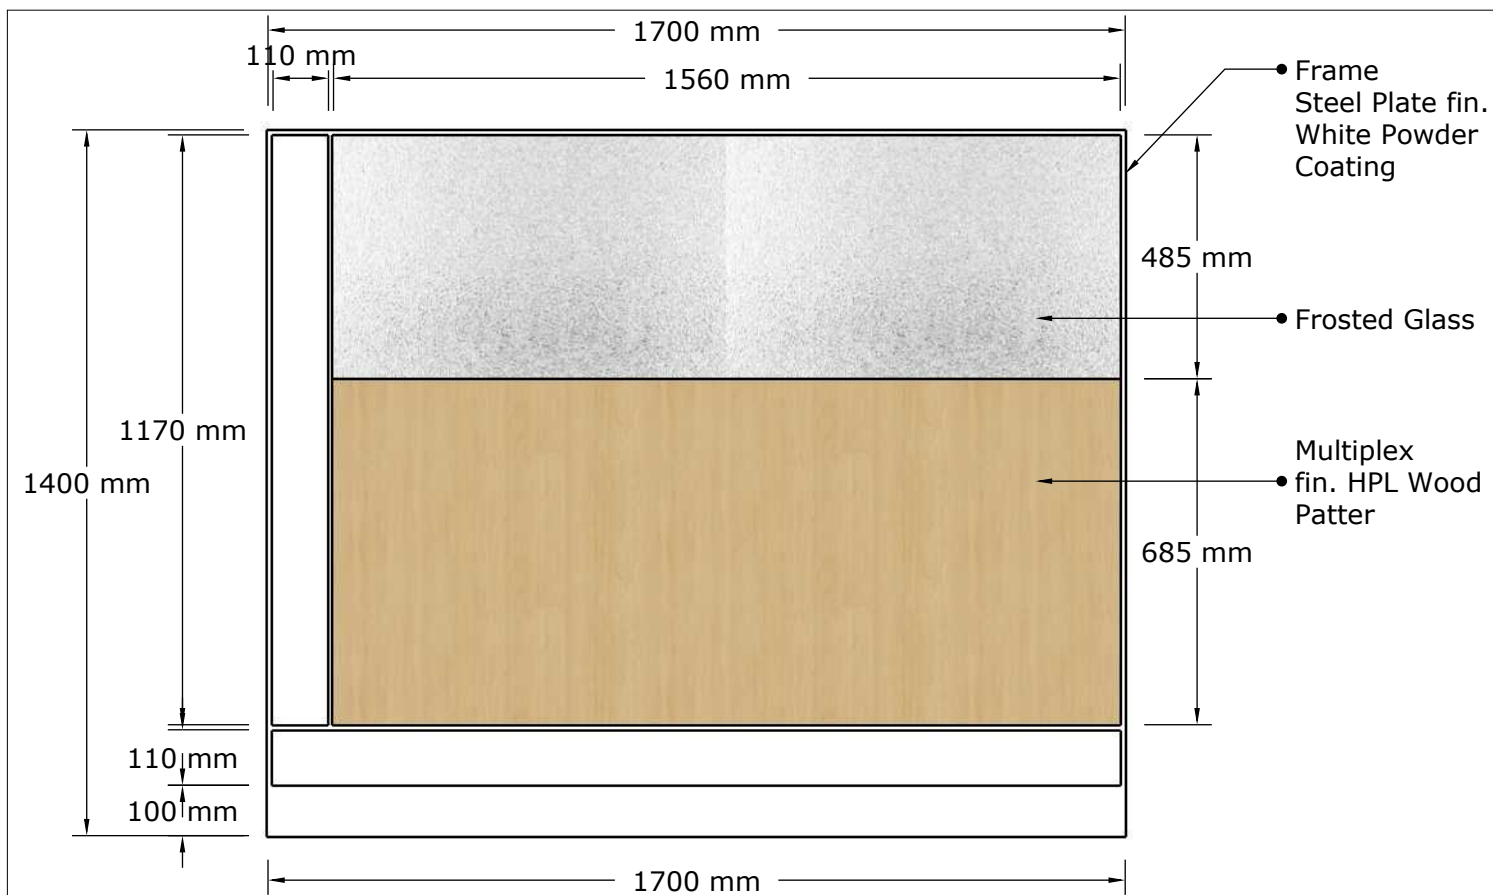


FRONT ELEVATION
SCALE 1:15

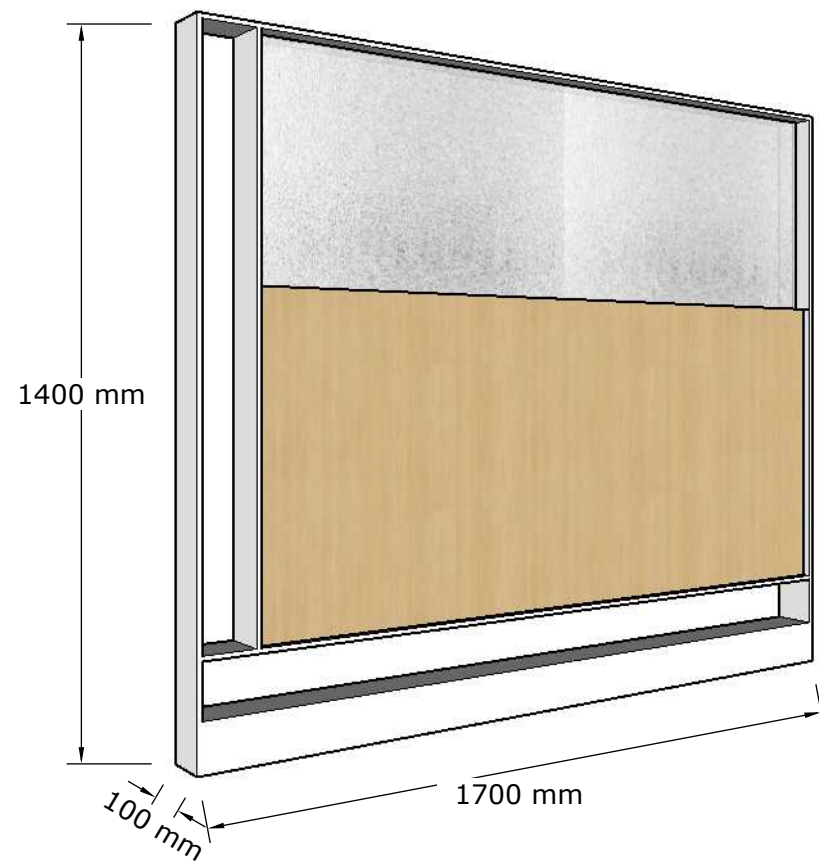


PERSPECTIVE
SCALE NTS

DV-01
DIVIDER WORKSTATION

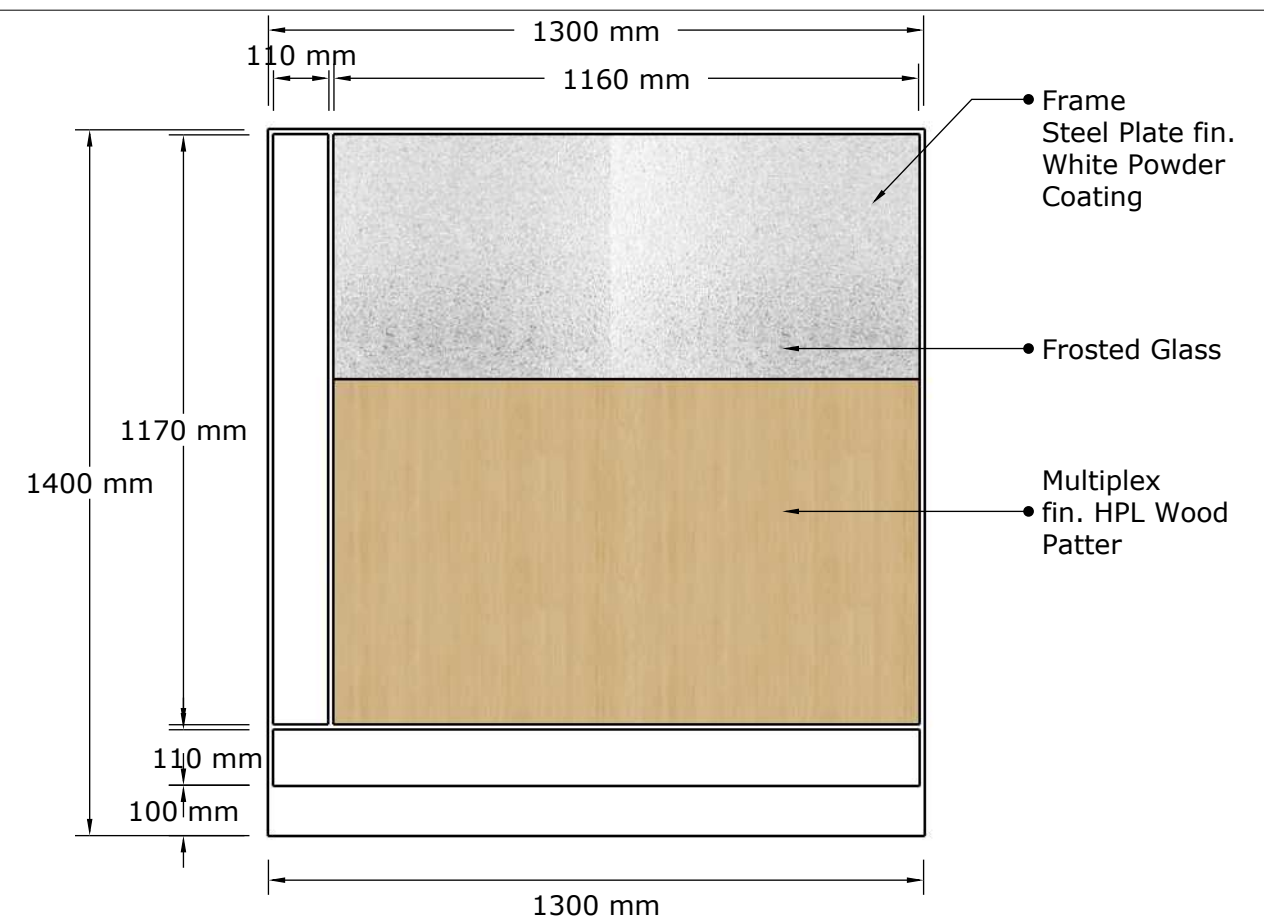


FRONT ELEVATION
SCALE 1:15

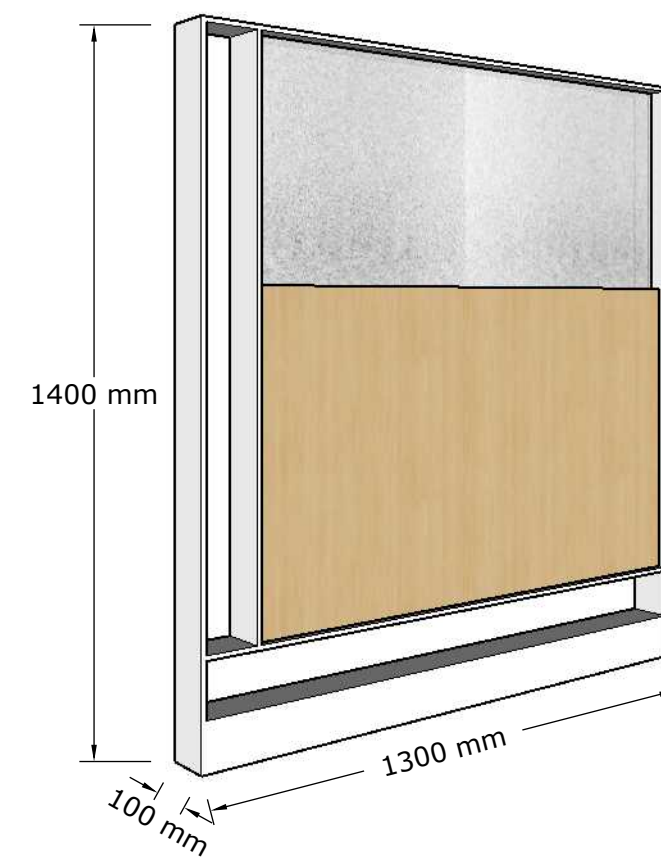


PERSPECTIVE
SCALE NTS

DV-02
DIVIDER WORKSTATION

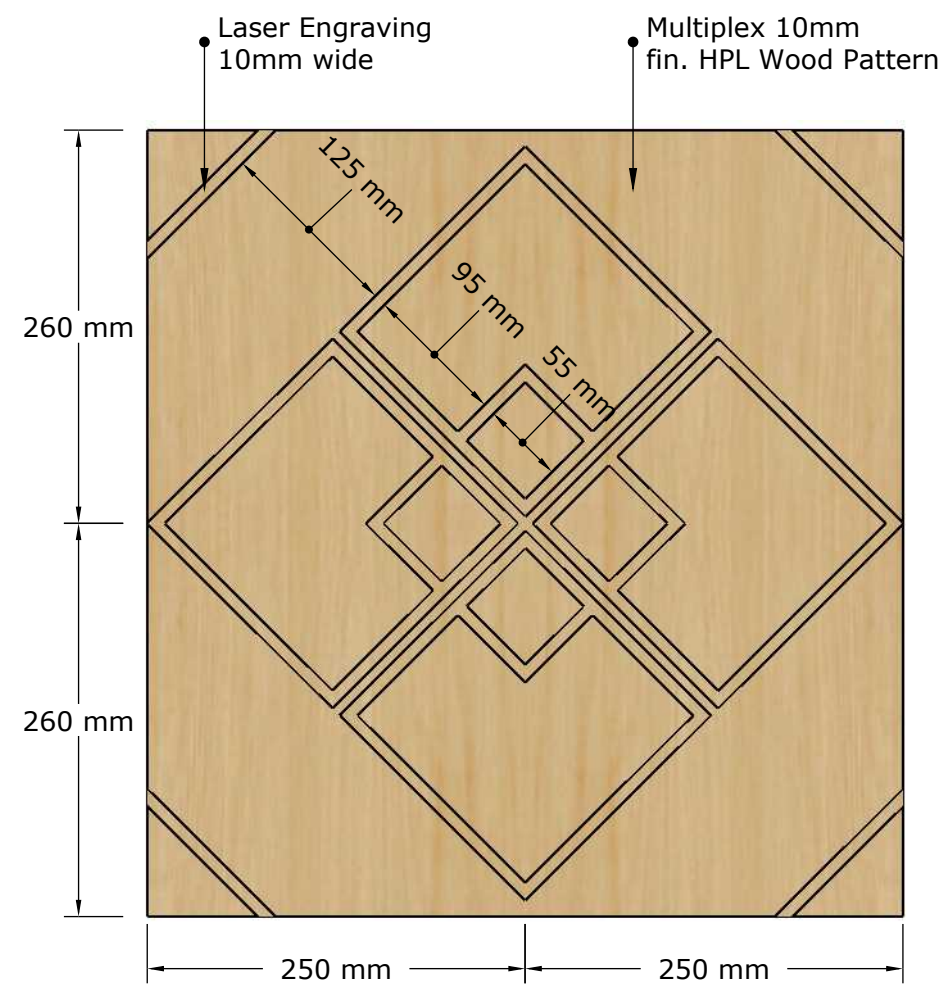


FRONT ELEVATION
SCALE 1:5

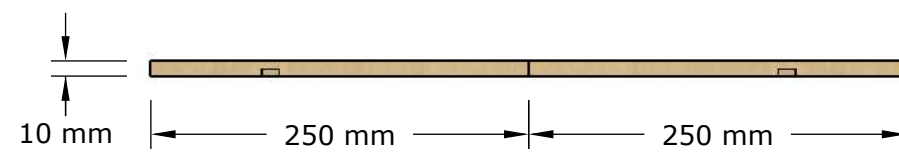


TOP VIEW
SCALE 1:5

MANAGER'S ROOM PANEL MODUL 2x5 UNITS

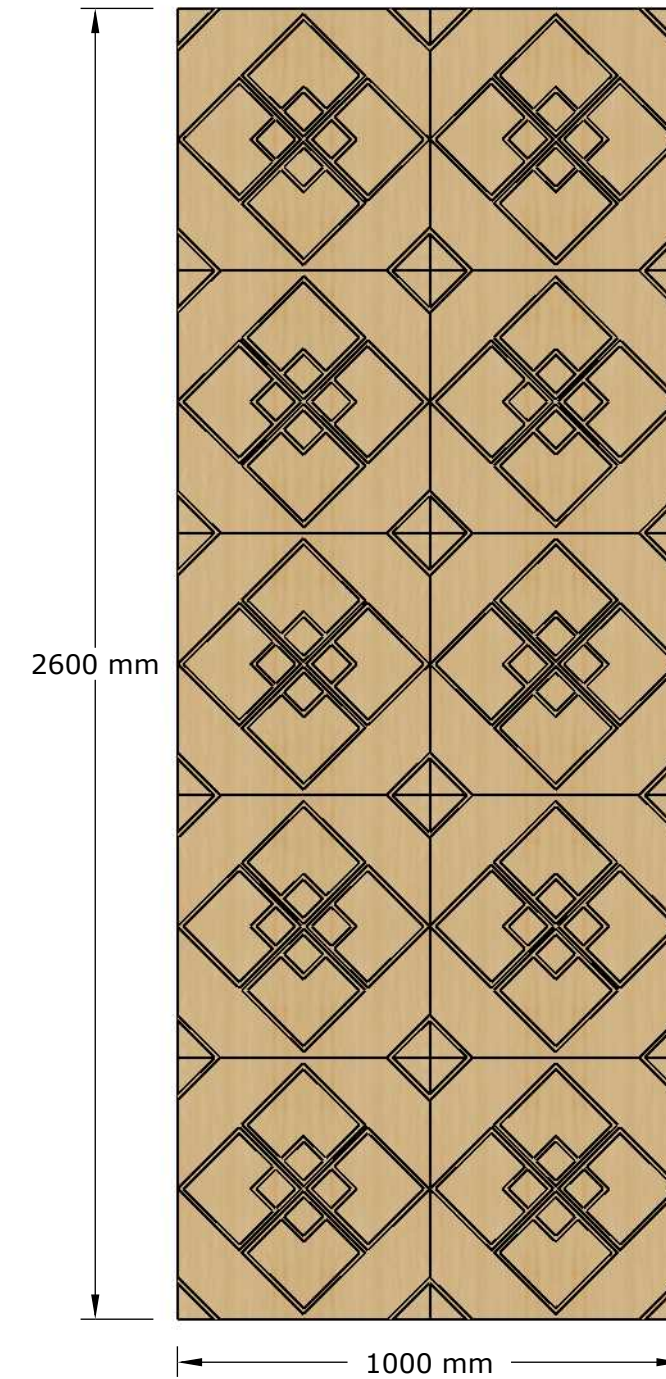


FRONT ELEVATION
SCALE 1:15

WORKSTATION PANEL
MODUL 1x5 UNITS

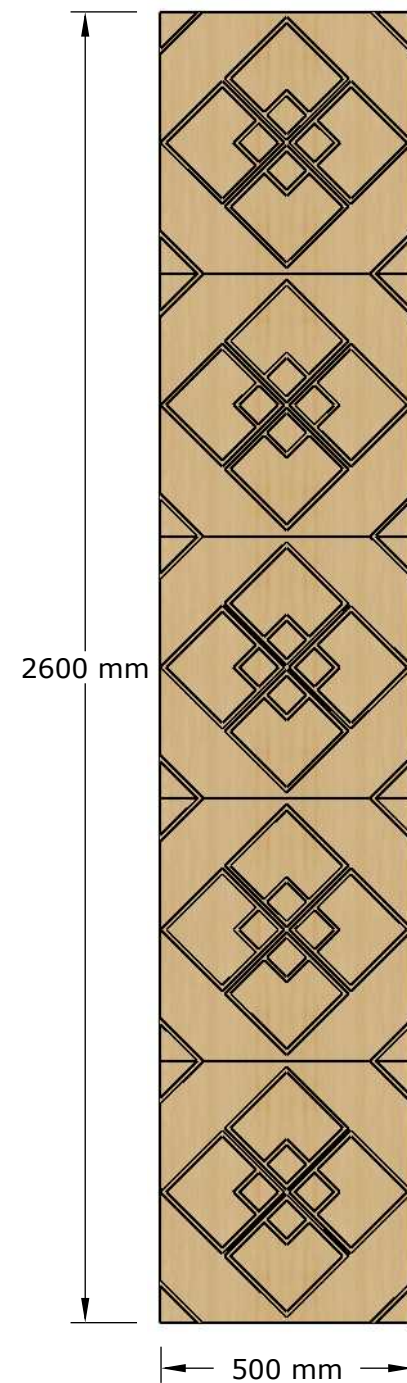


FRONT ELEVATION
SCALE 1:15

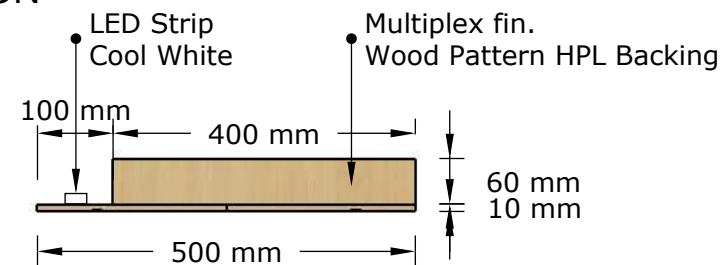


TOP VIEW
SCALE 1:10


DIRECTOR'S ROOM PANEL
MODUL 3x5 UNITS

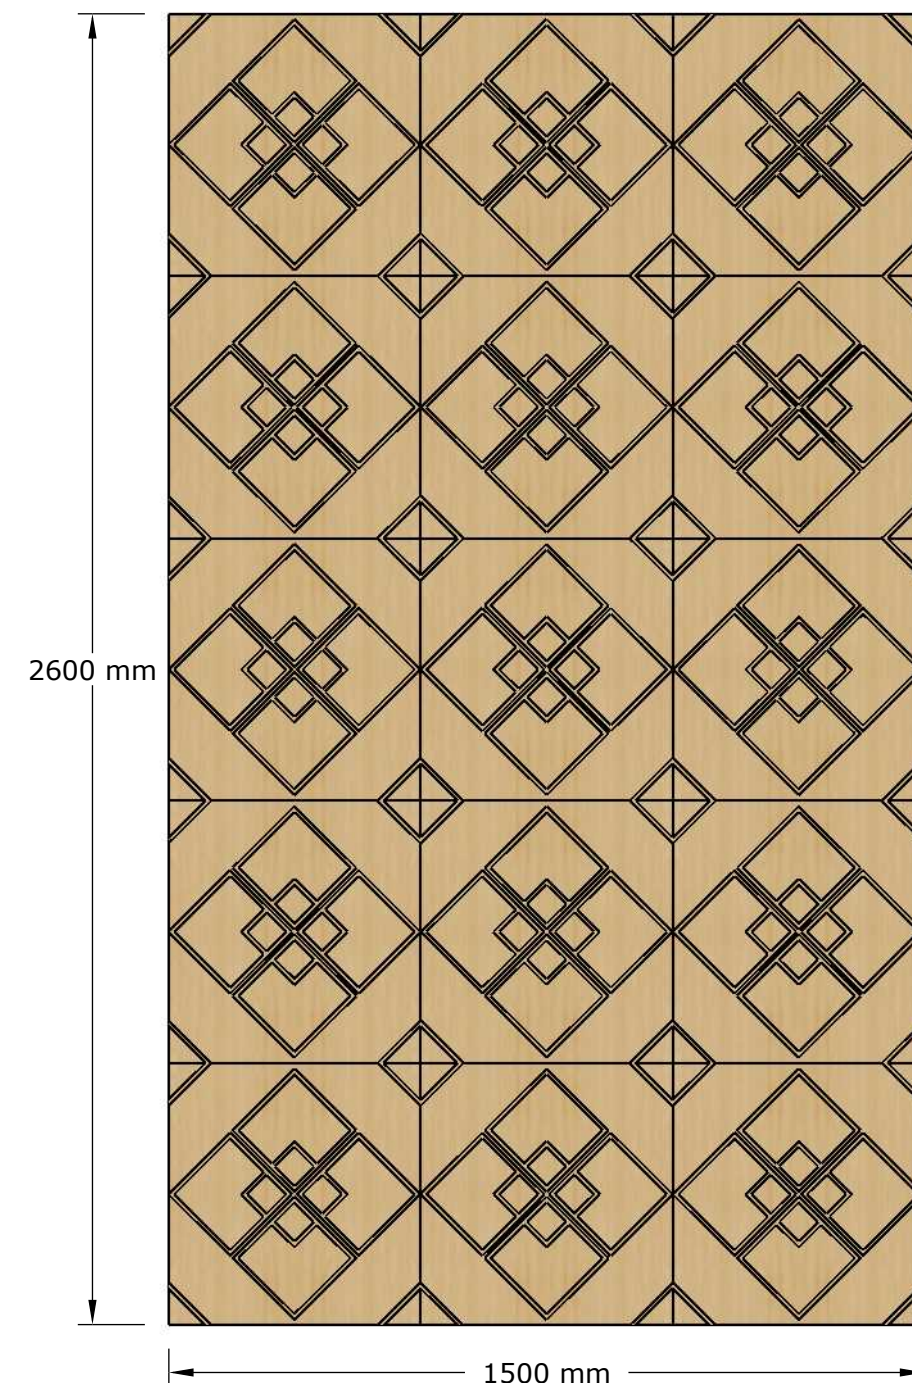


FRONT ELEVATION
SCALE 1:15

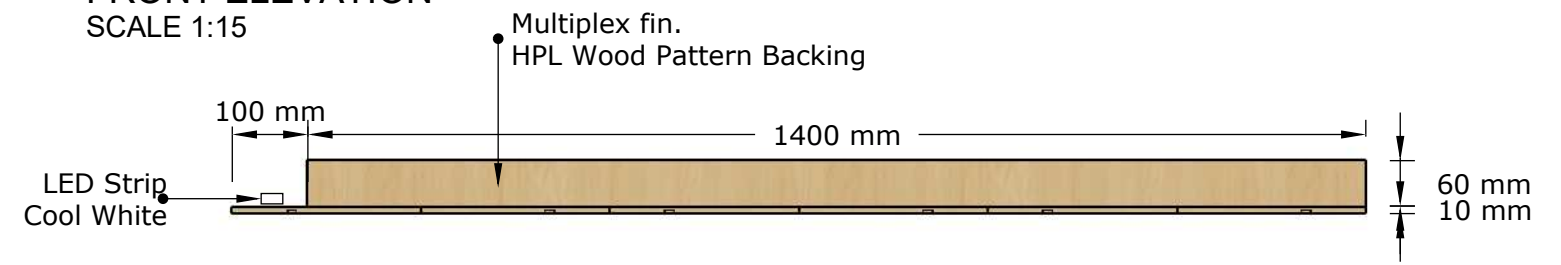


TOP VIEW
SCALE 1:10

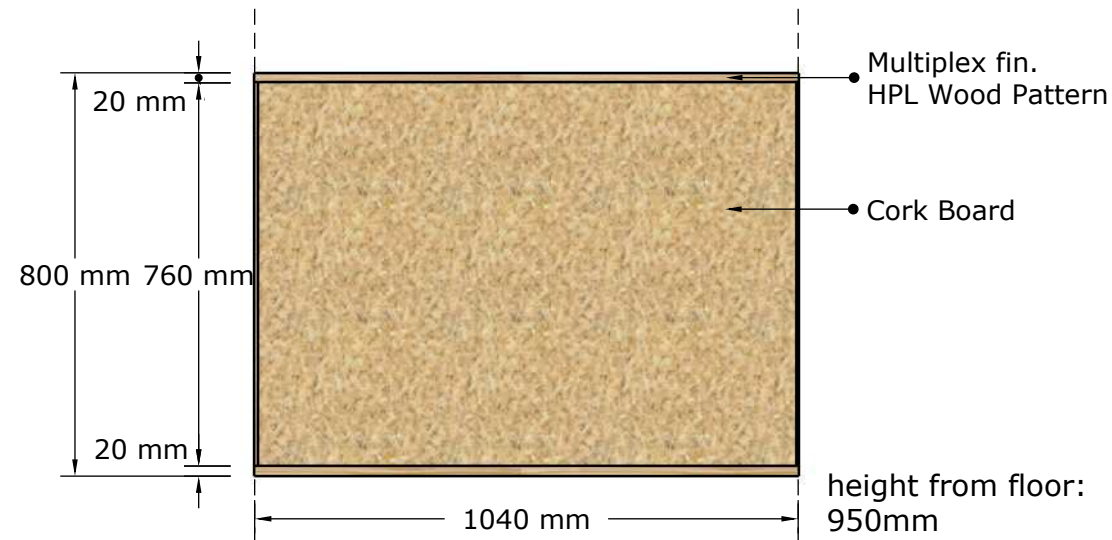

FRONT ELEVATION
SCALE 1:15

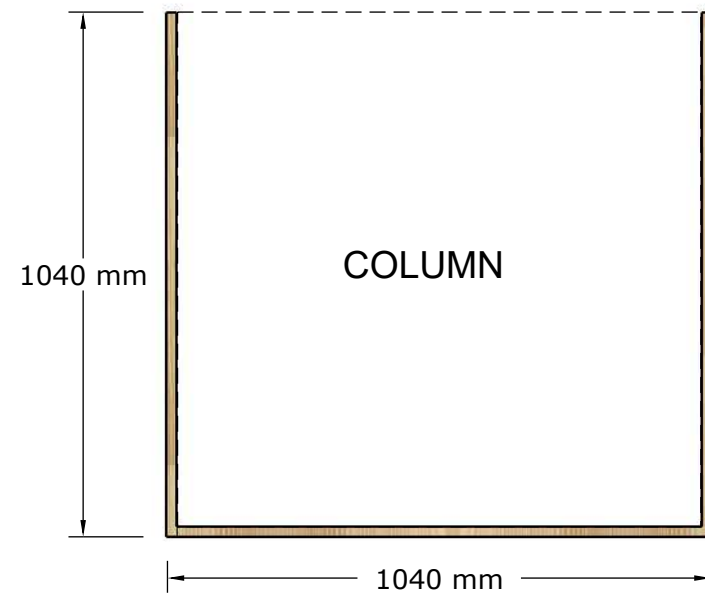


TOP VIEW
SCALE 1:15

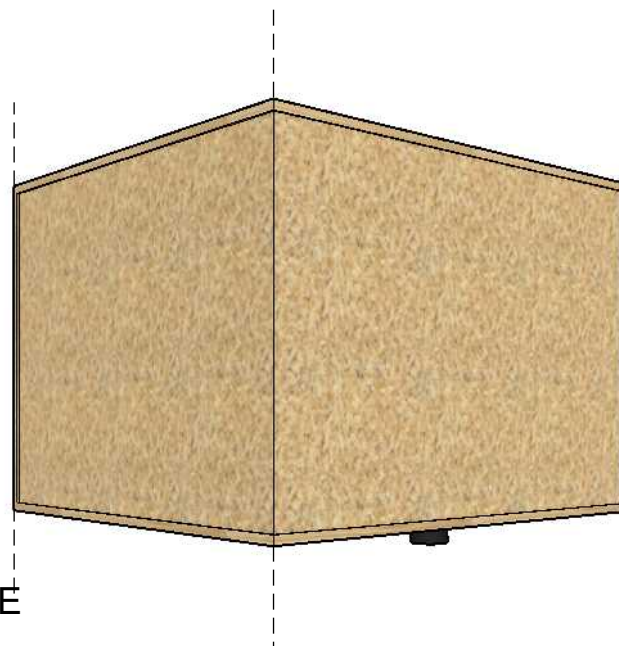


PERSPECTIVE
SCALE NTS


PNL-02
CORK PANEL

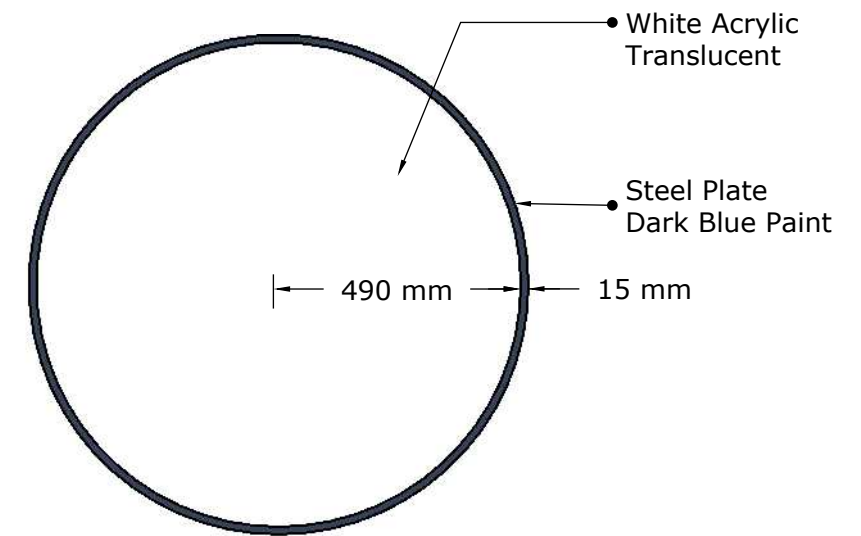

BOTTOM VIEW
SCALE 1:15

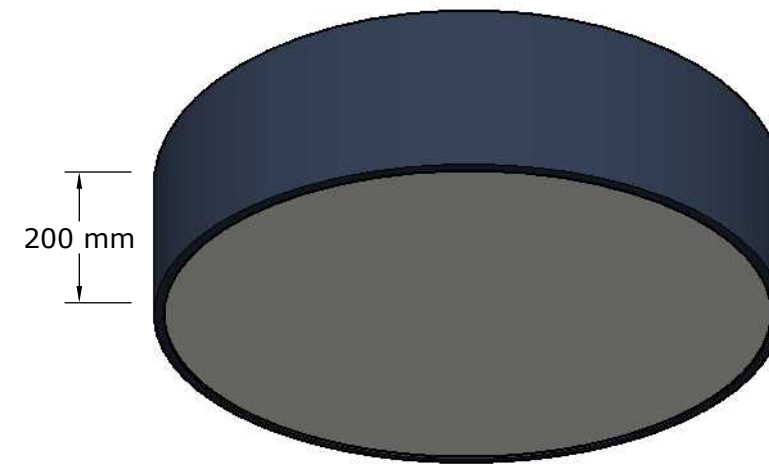

PERSPECTIVE
SCALE 1:15

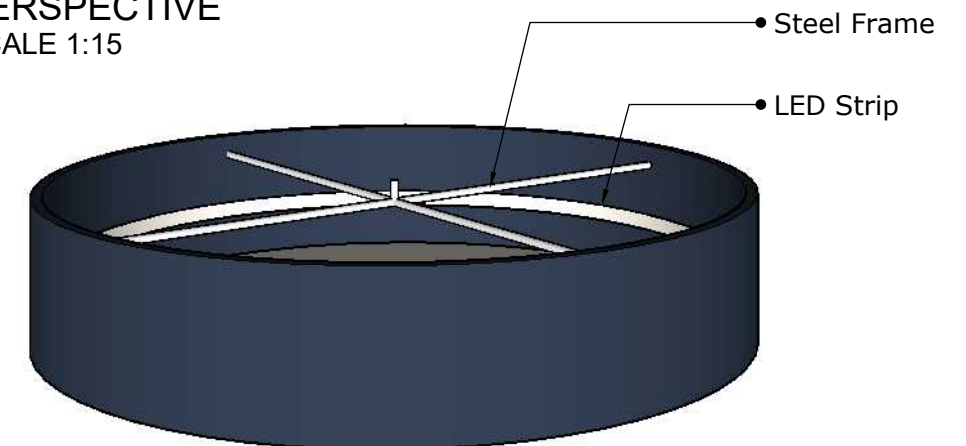

PERSPECTIVE
SCALE 1:15

LMP-01
PENDANT LAMP