

UNDP OFFICE & RC OFFICE - EAST WING
SECOND FLOOR, UN HOUSE, PULCHOWK, NEPAL.


COMPLETE DRAWINGS

JULY 2019

INTERIOR DESIGN OF RESIDENT CO-ORDINATOR'S OFFICE
SECOND FLOOR, EAST WING, UN HOUSE, PULCHOWK, NEPAL.

DRAWINGS

JULY 2019

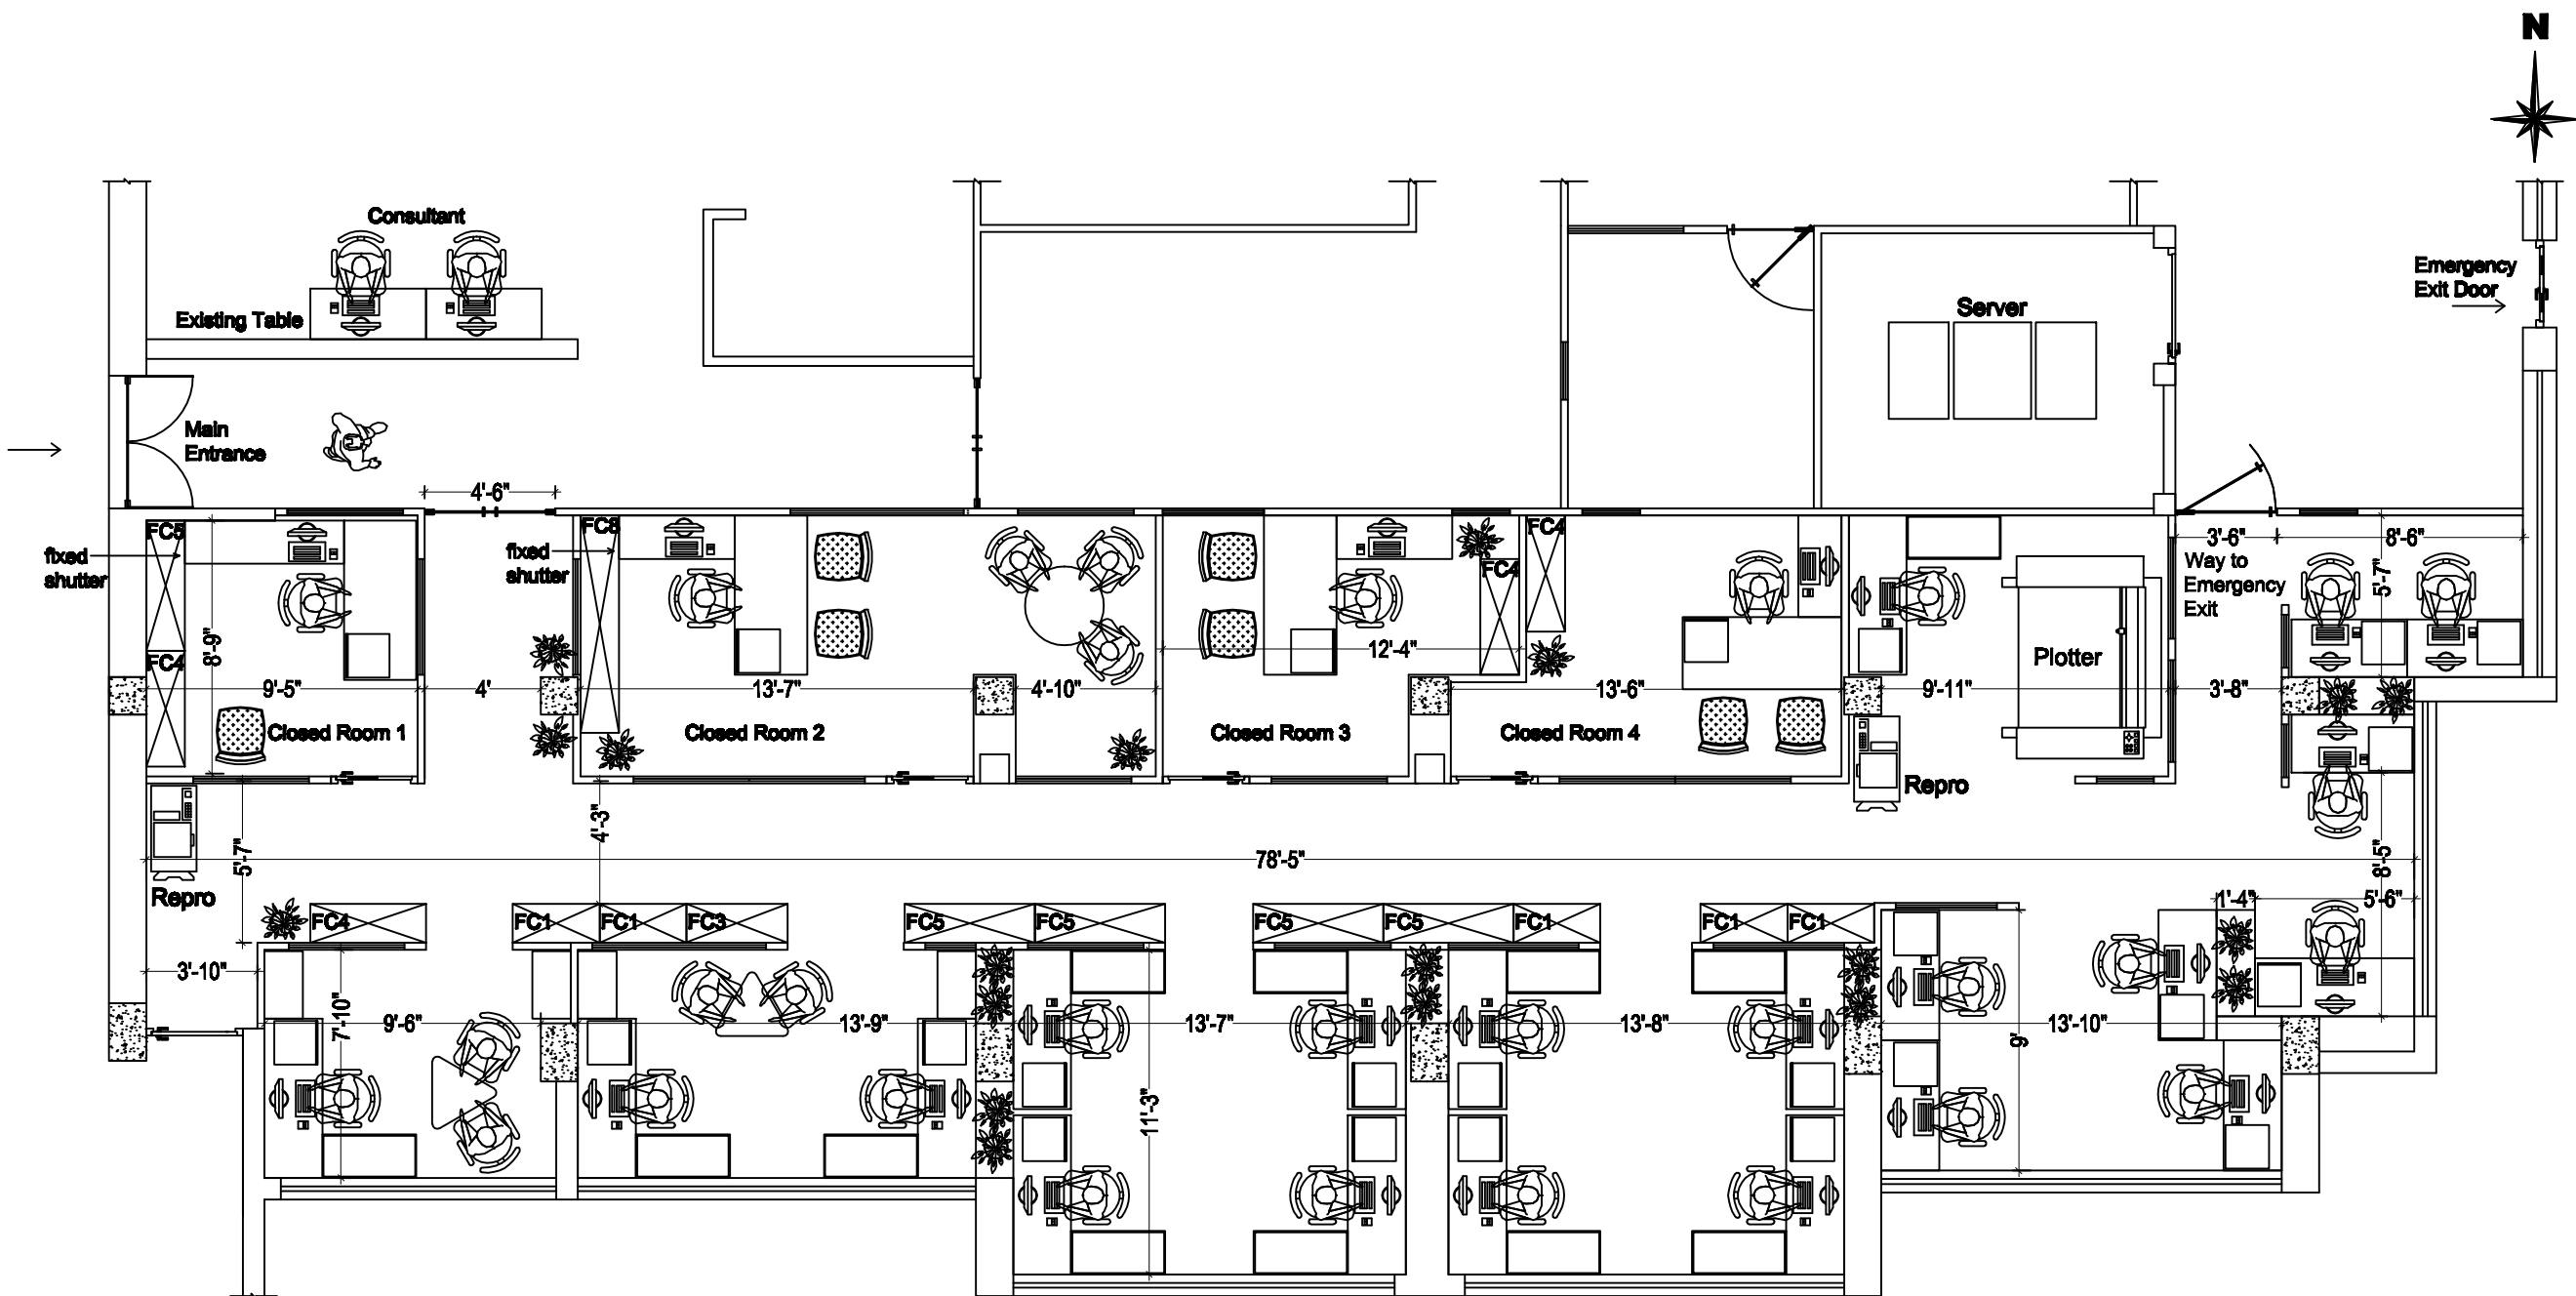

Project:

Resident Co-ordinator's Office
UN Main Building, (SOUTH SIDE) East Wing, Second Floor

FURNITURE LAYOUT


Second Floor

D
E
S
I
G
N

Date: JULY 2019

Sheet No.:

01

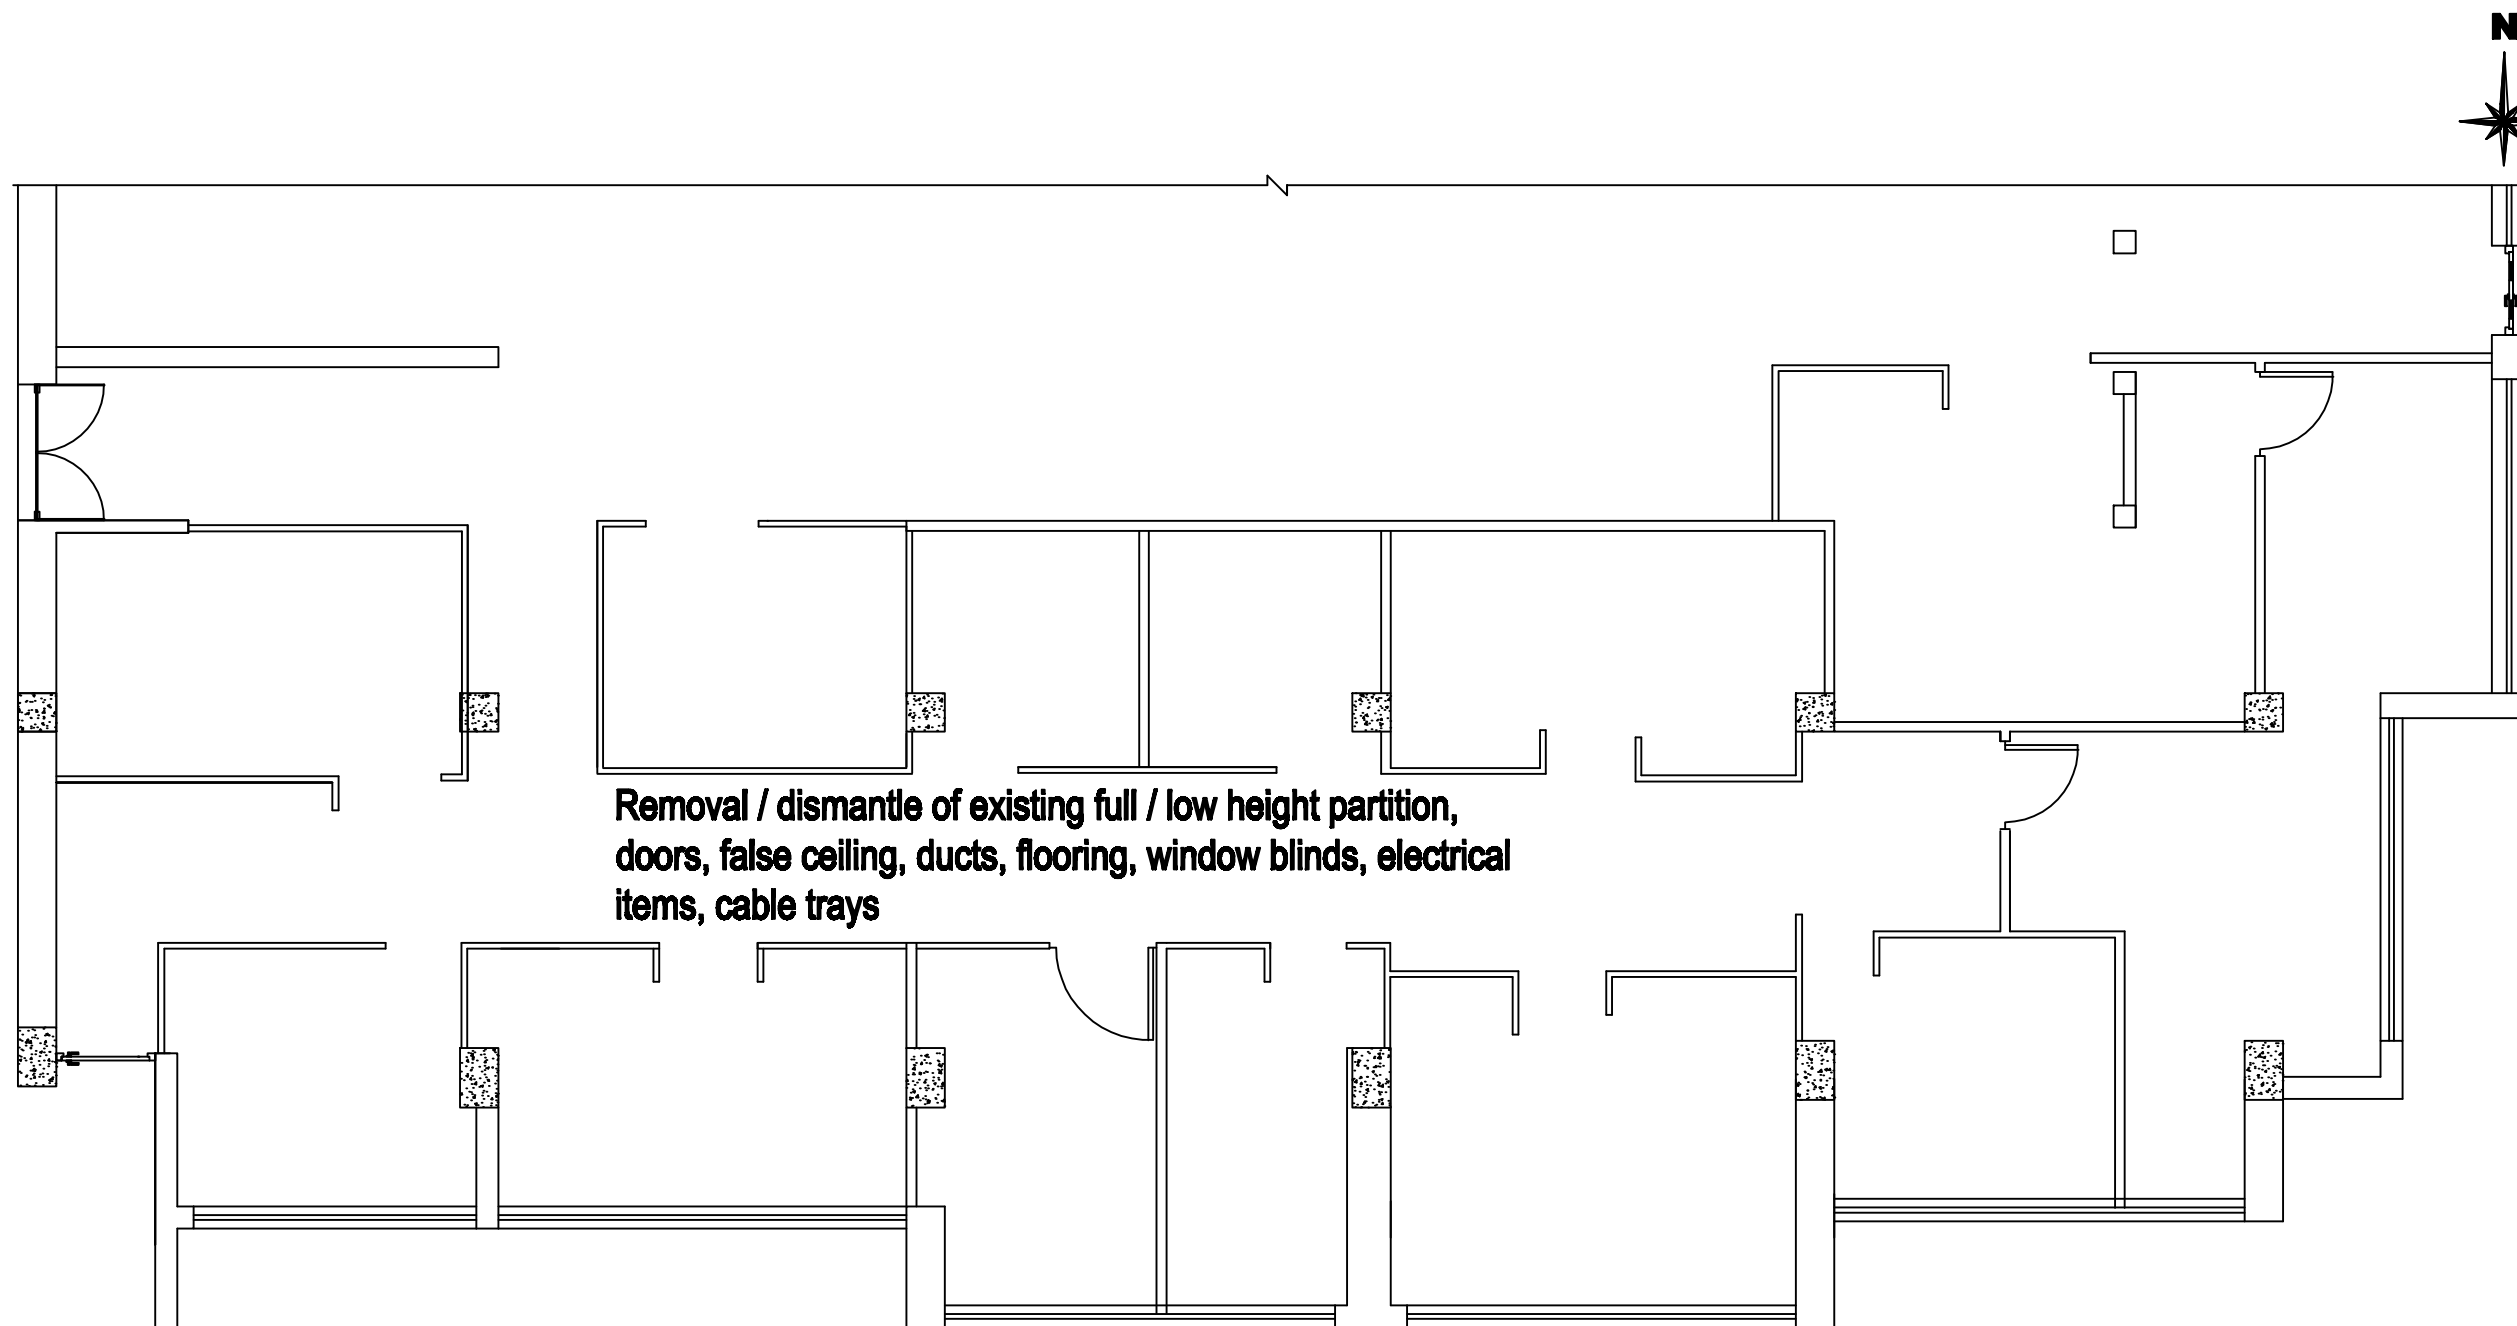

Project:

Resident Co-ordinator's Office

UN Main Building, (SOUTH SIDE) East Wing, Second Floor

DISMANTLE LAYOUT


Second Floor

D
E
S
I
G
N

Date: JULY 2019

Sheet No.:

02

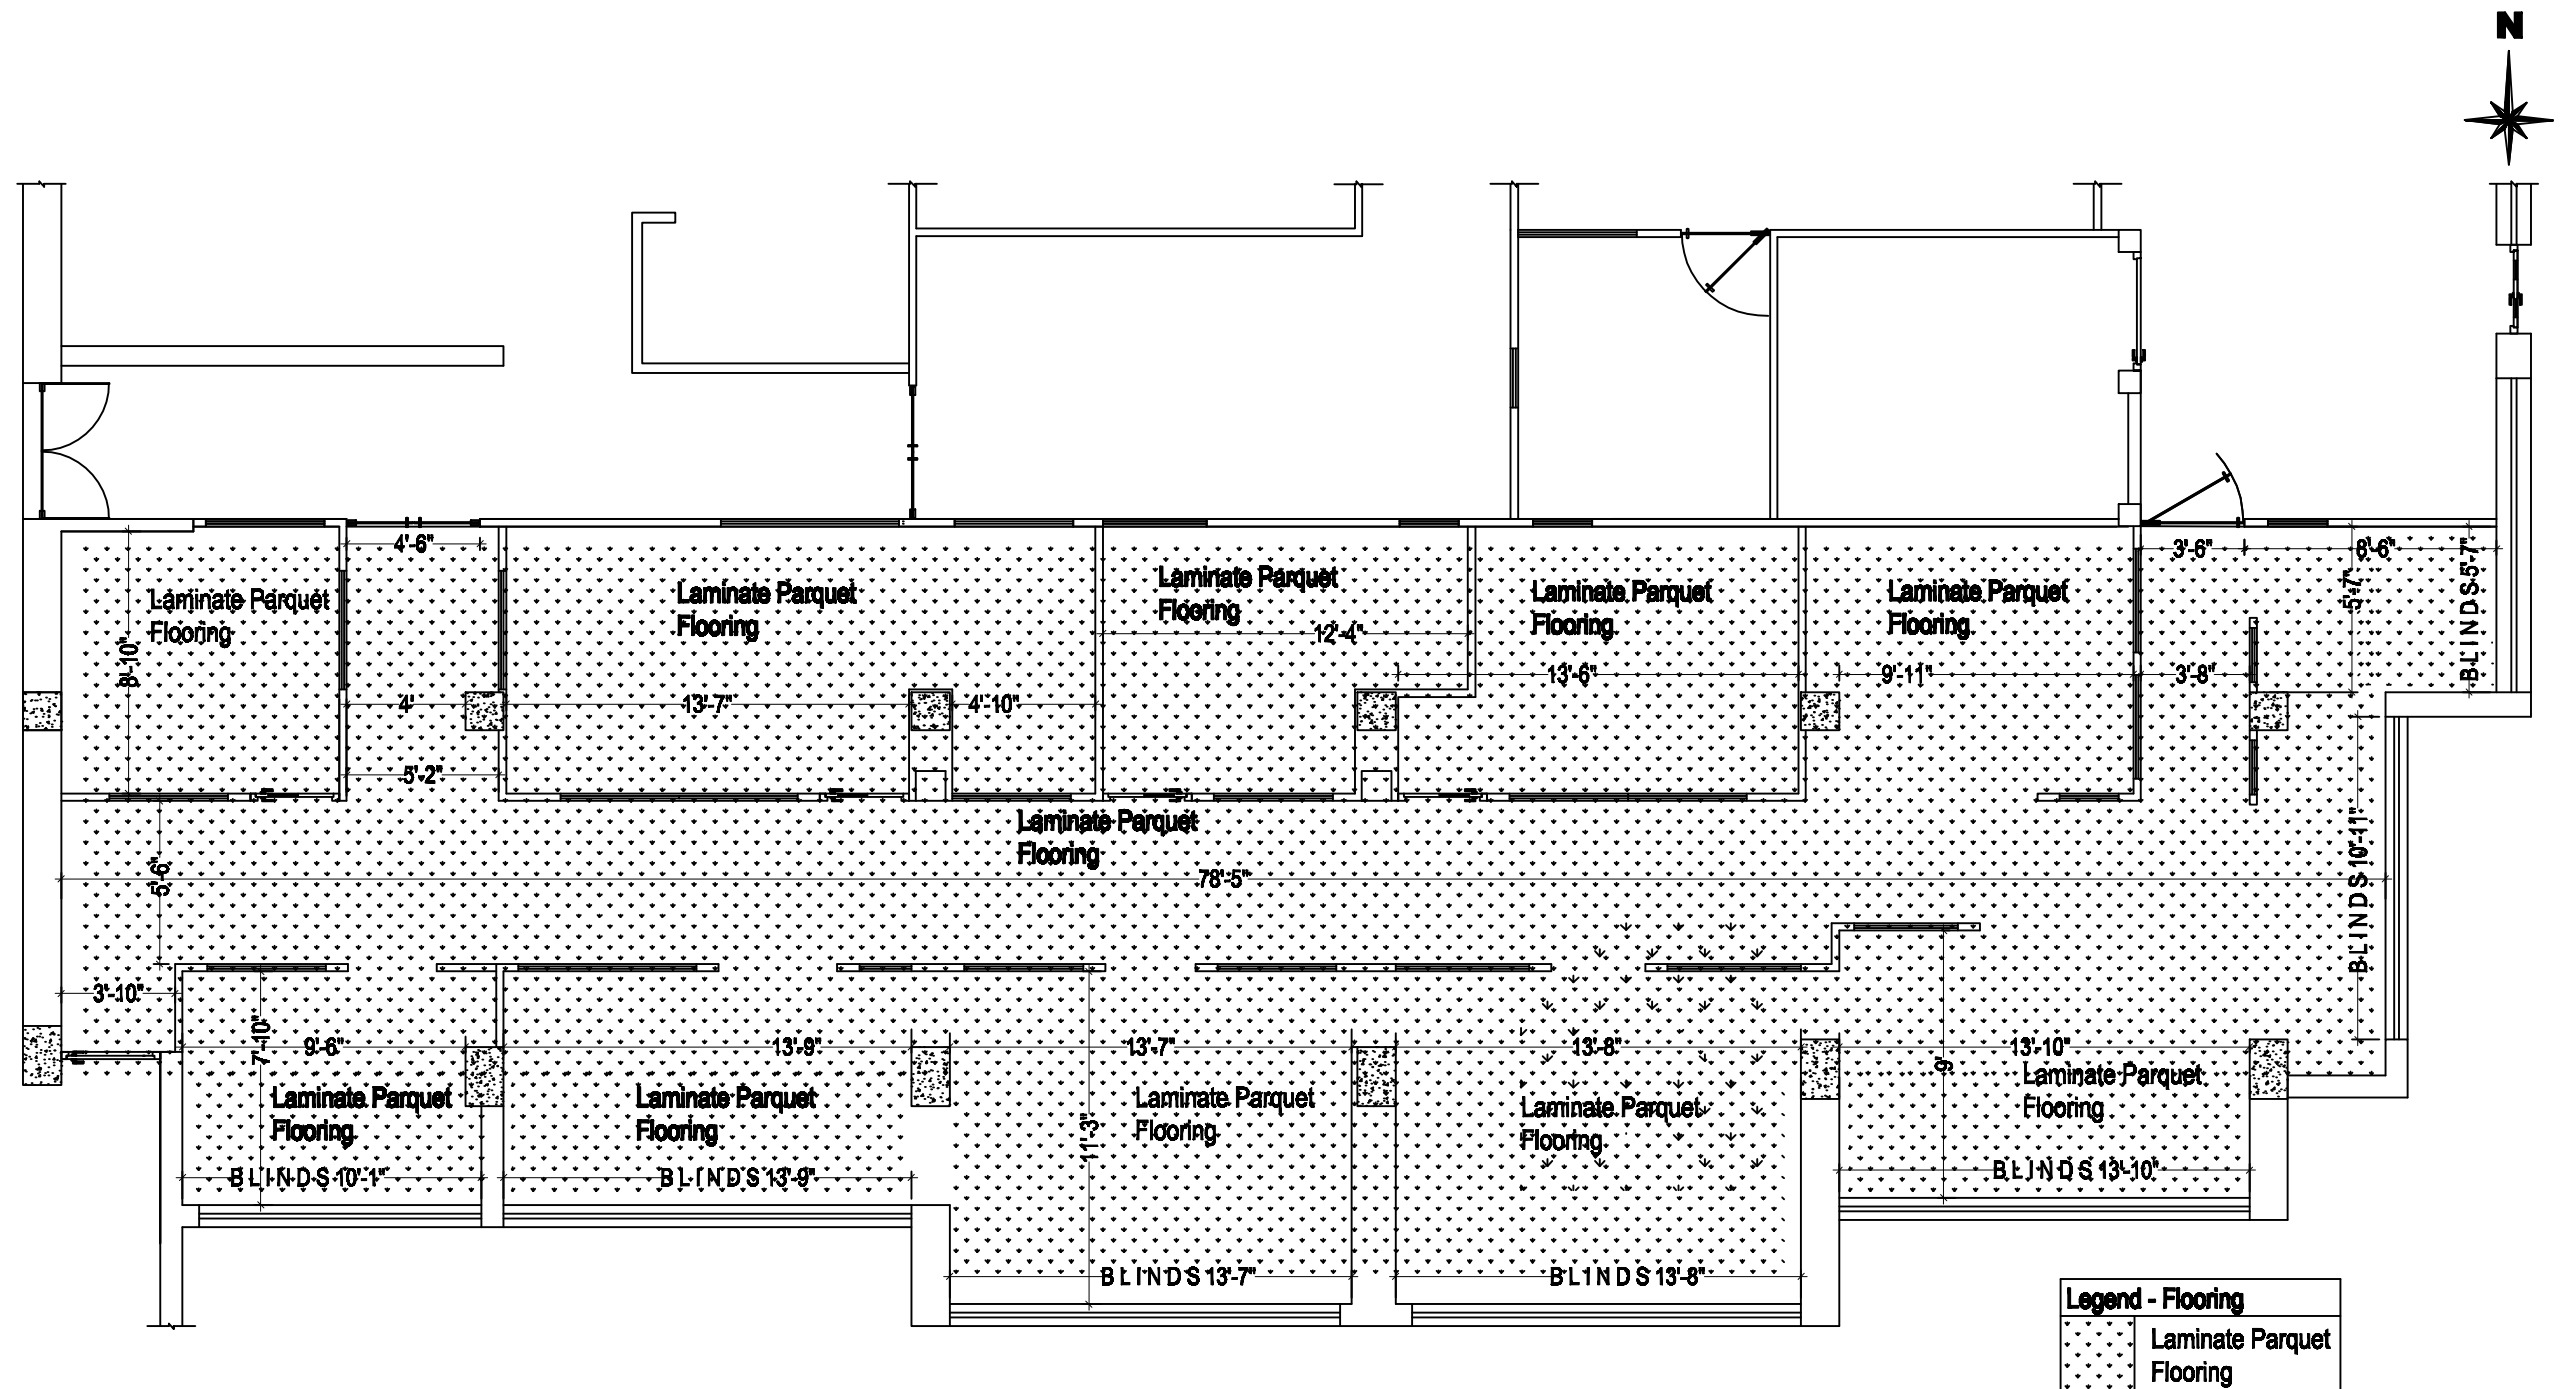

Project:

Resident Co-ordinator's Office
UN Main Building, (SOUTH SIDE) East Wing, Second Floor


FLOORING / FURNISHING
Second Floor

**D
E
S
I
G
N**

Date: JULY 2019

Sheet No.:

03

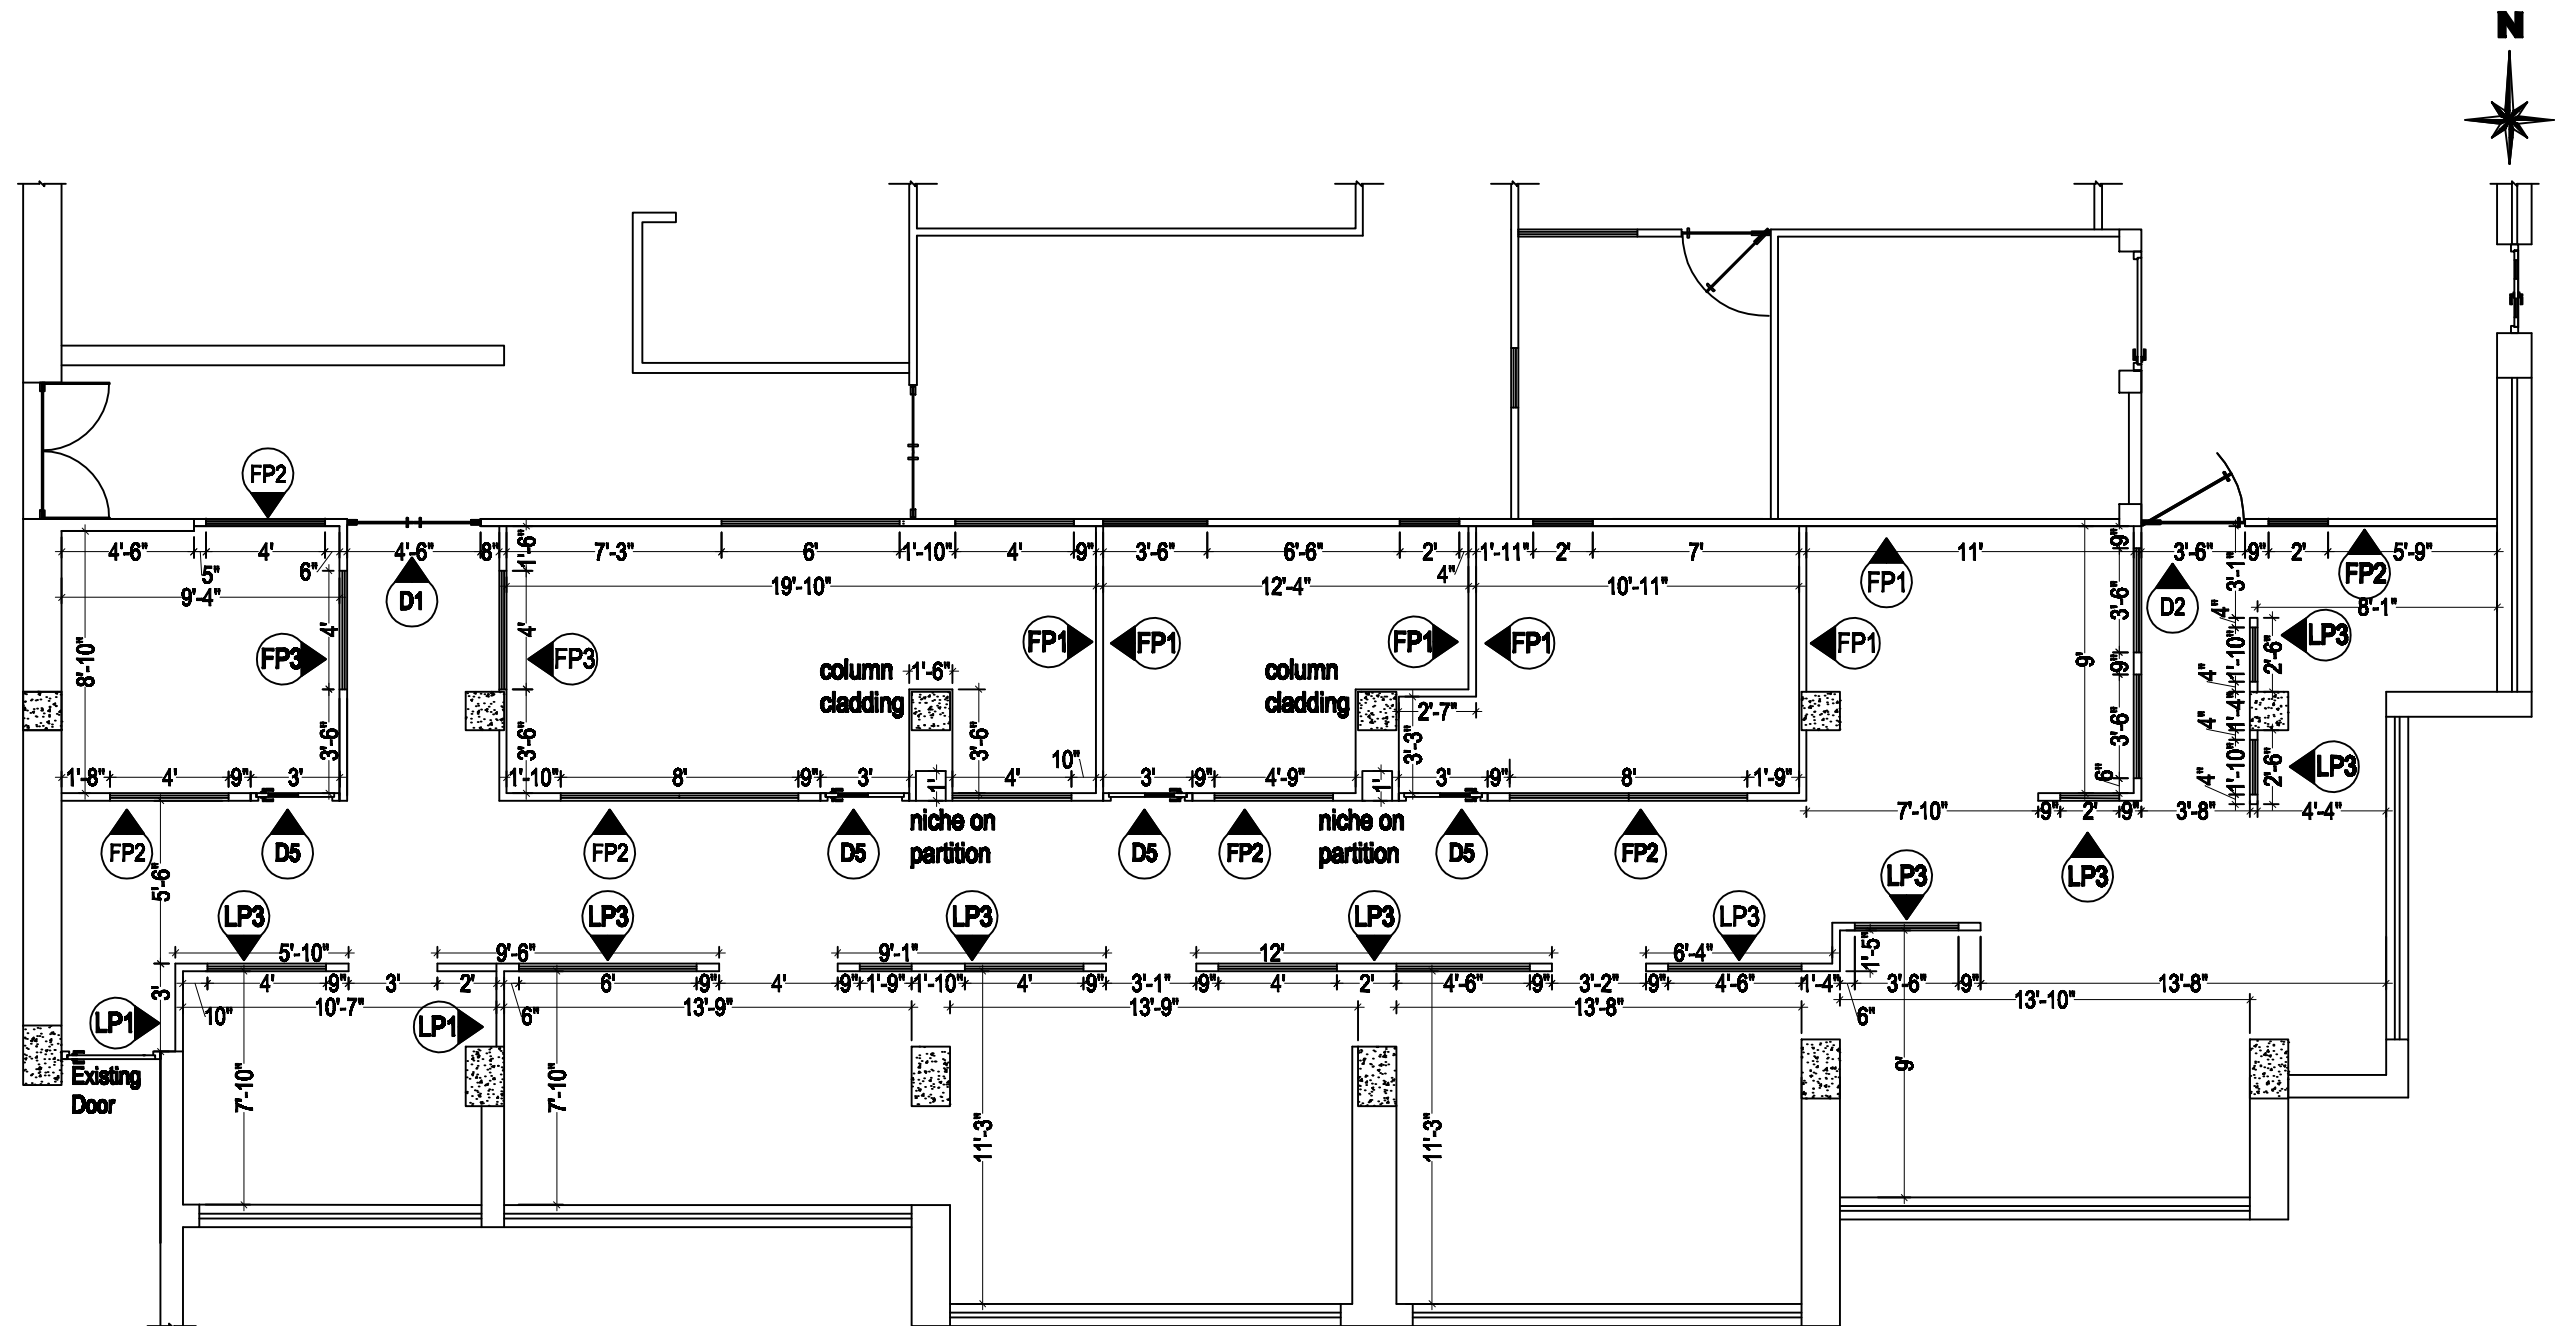

Project:

Resident Co-ordinator's Office
UN Main Building, (SOUTH SIDE) East Wing, Second Floor


PARTITION LAYOUT
Second Floor

DESIGN

Date: JULY 2019

Sheet No.:

04

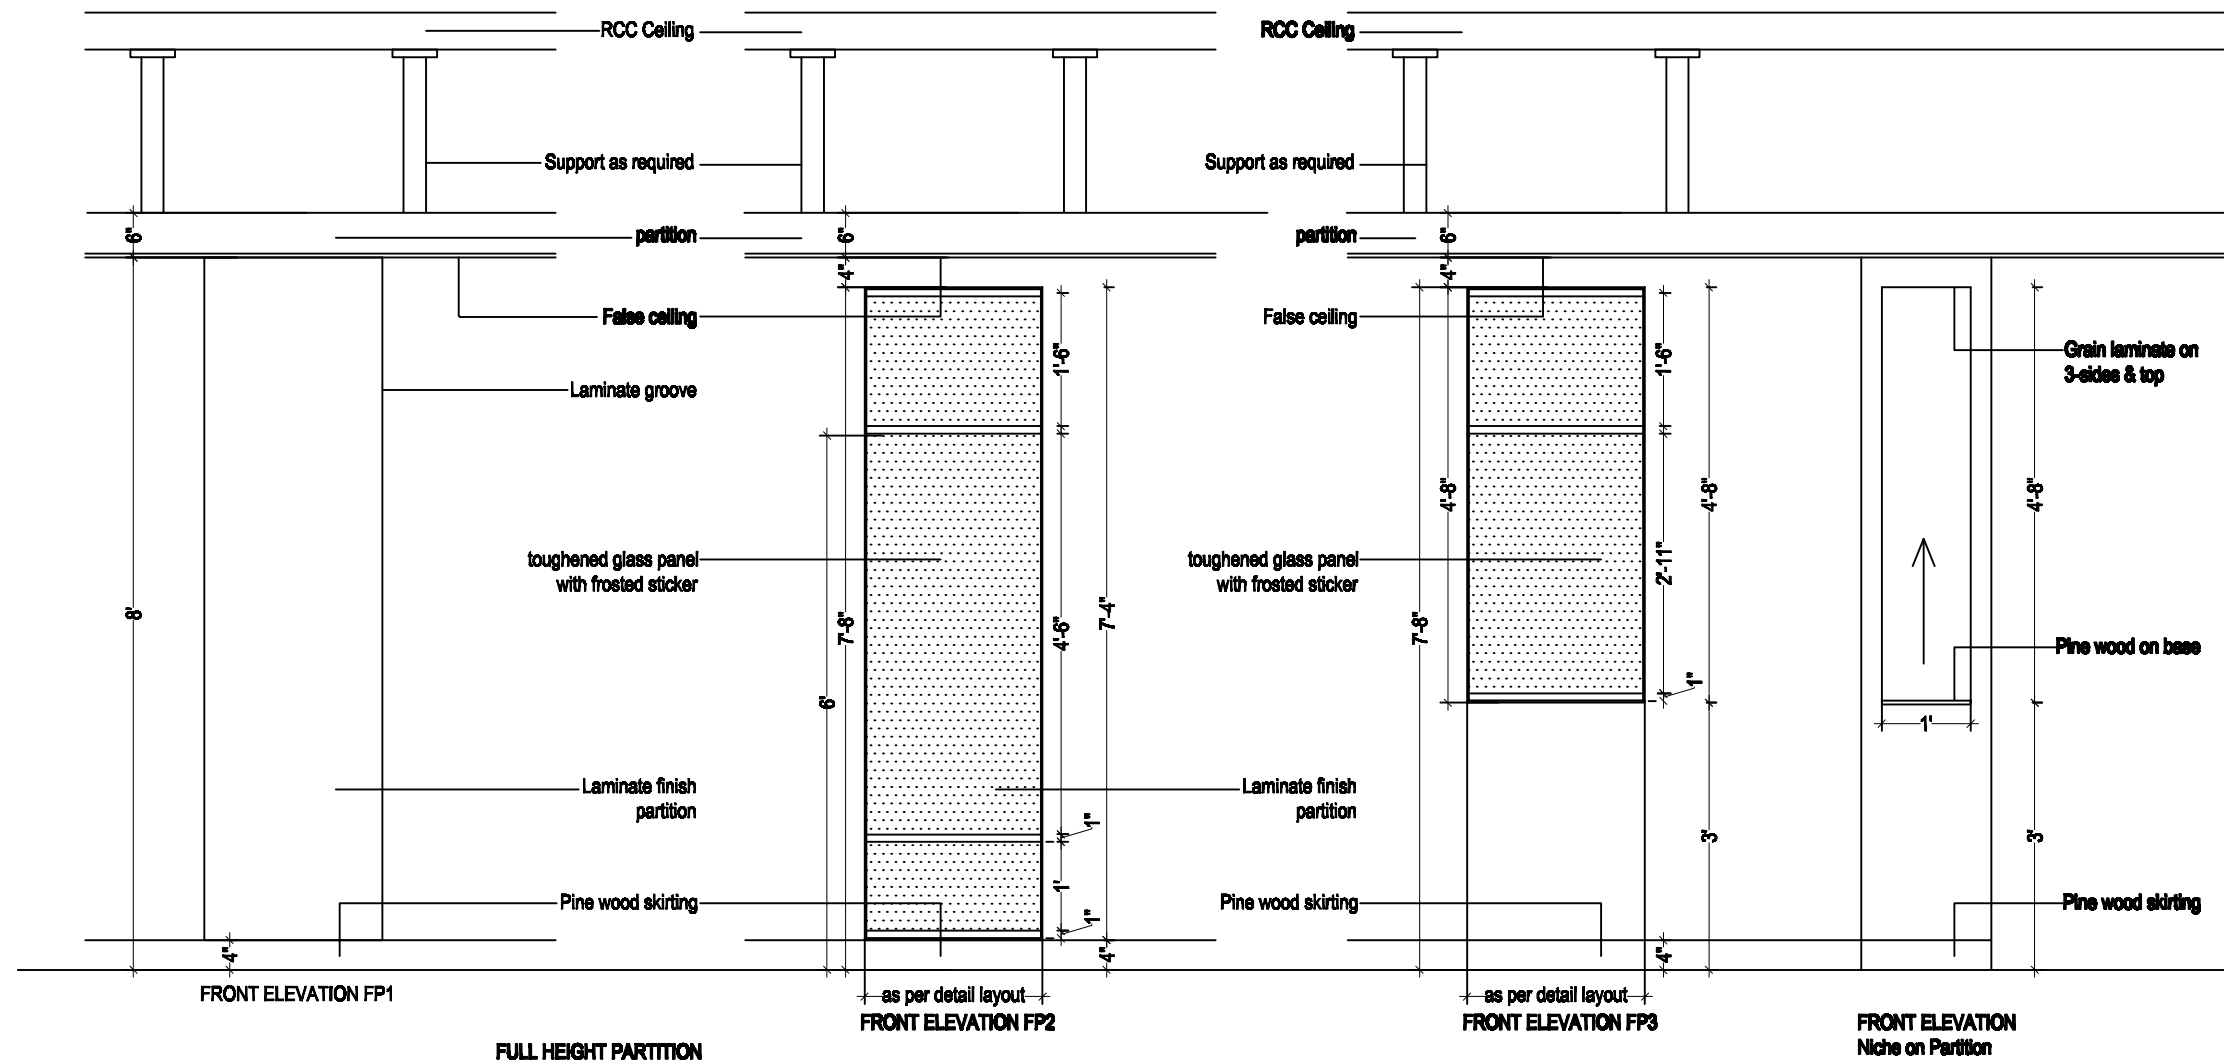

Project:

Resident Co-ordinator's Office
UN Main Building, (SOUTH SIDE) East Wing, Second Floor

PARTITION DETAIL
Second Floor



DESIGN

Date: JULY 2019

Sheet No.:

04a

04b

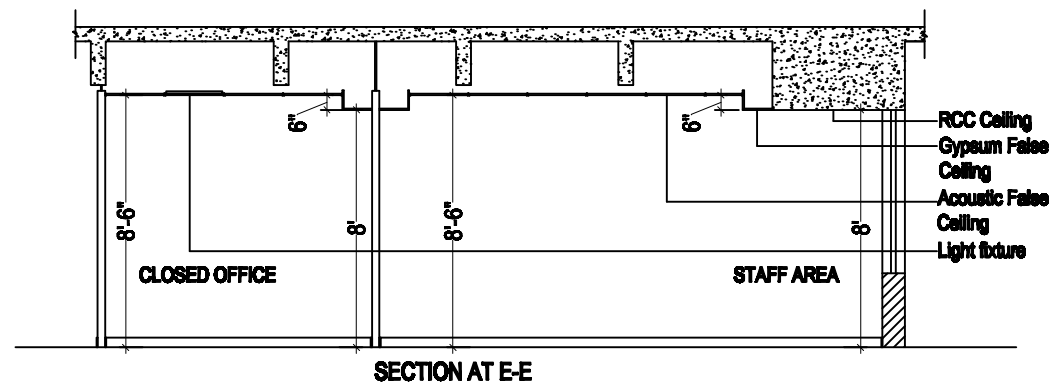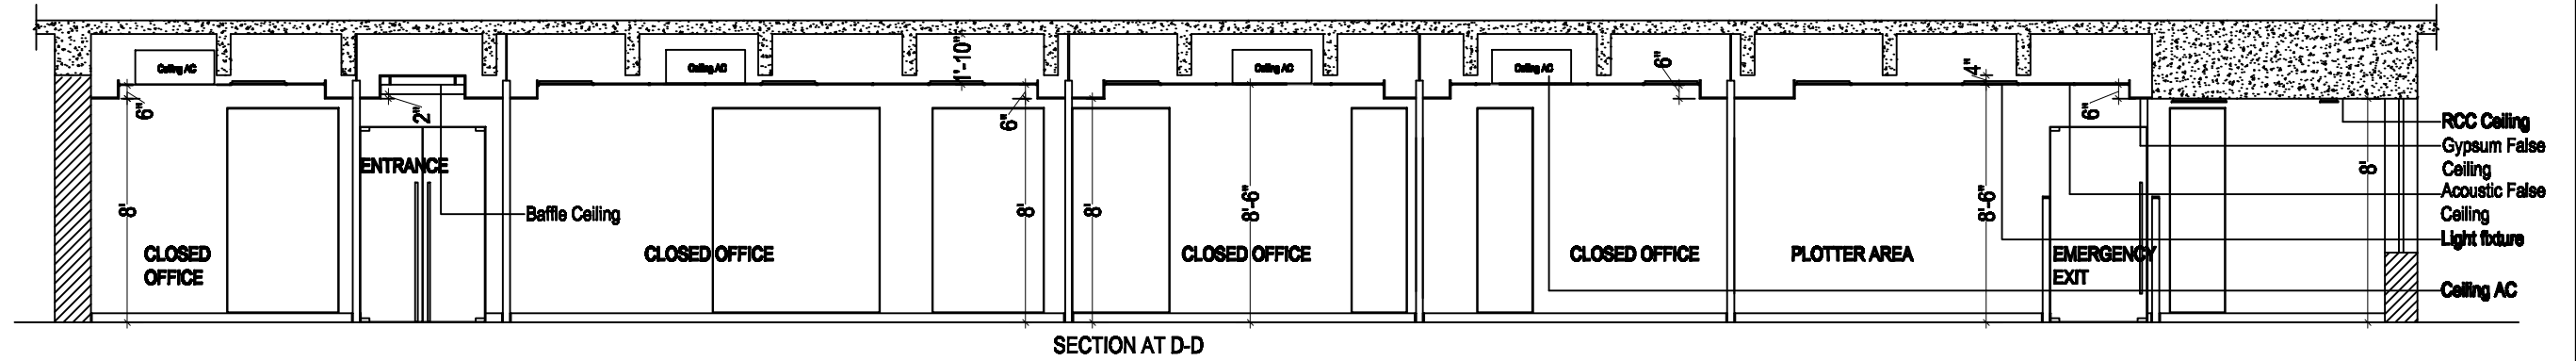

Project:

Resident Co-ordinator's Office
UN Main Building, (SOUTH SIDE) East Wing, Second Floor

FALSE CEILING SECTION DETAIL


Second Floor

D
E
S
I
G
N

Date: JULY 2019

Sheet No.:

05a

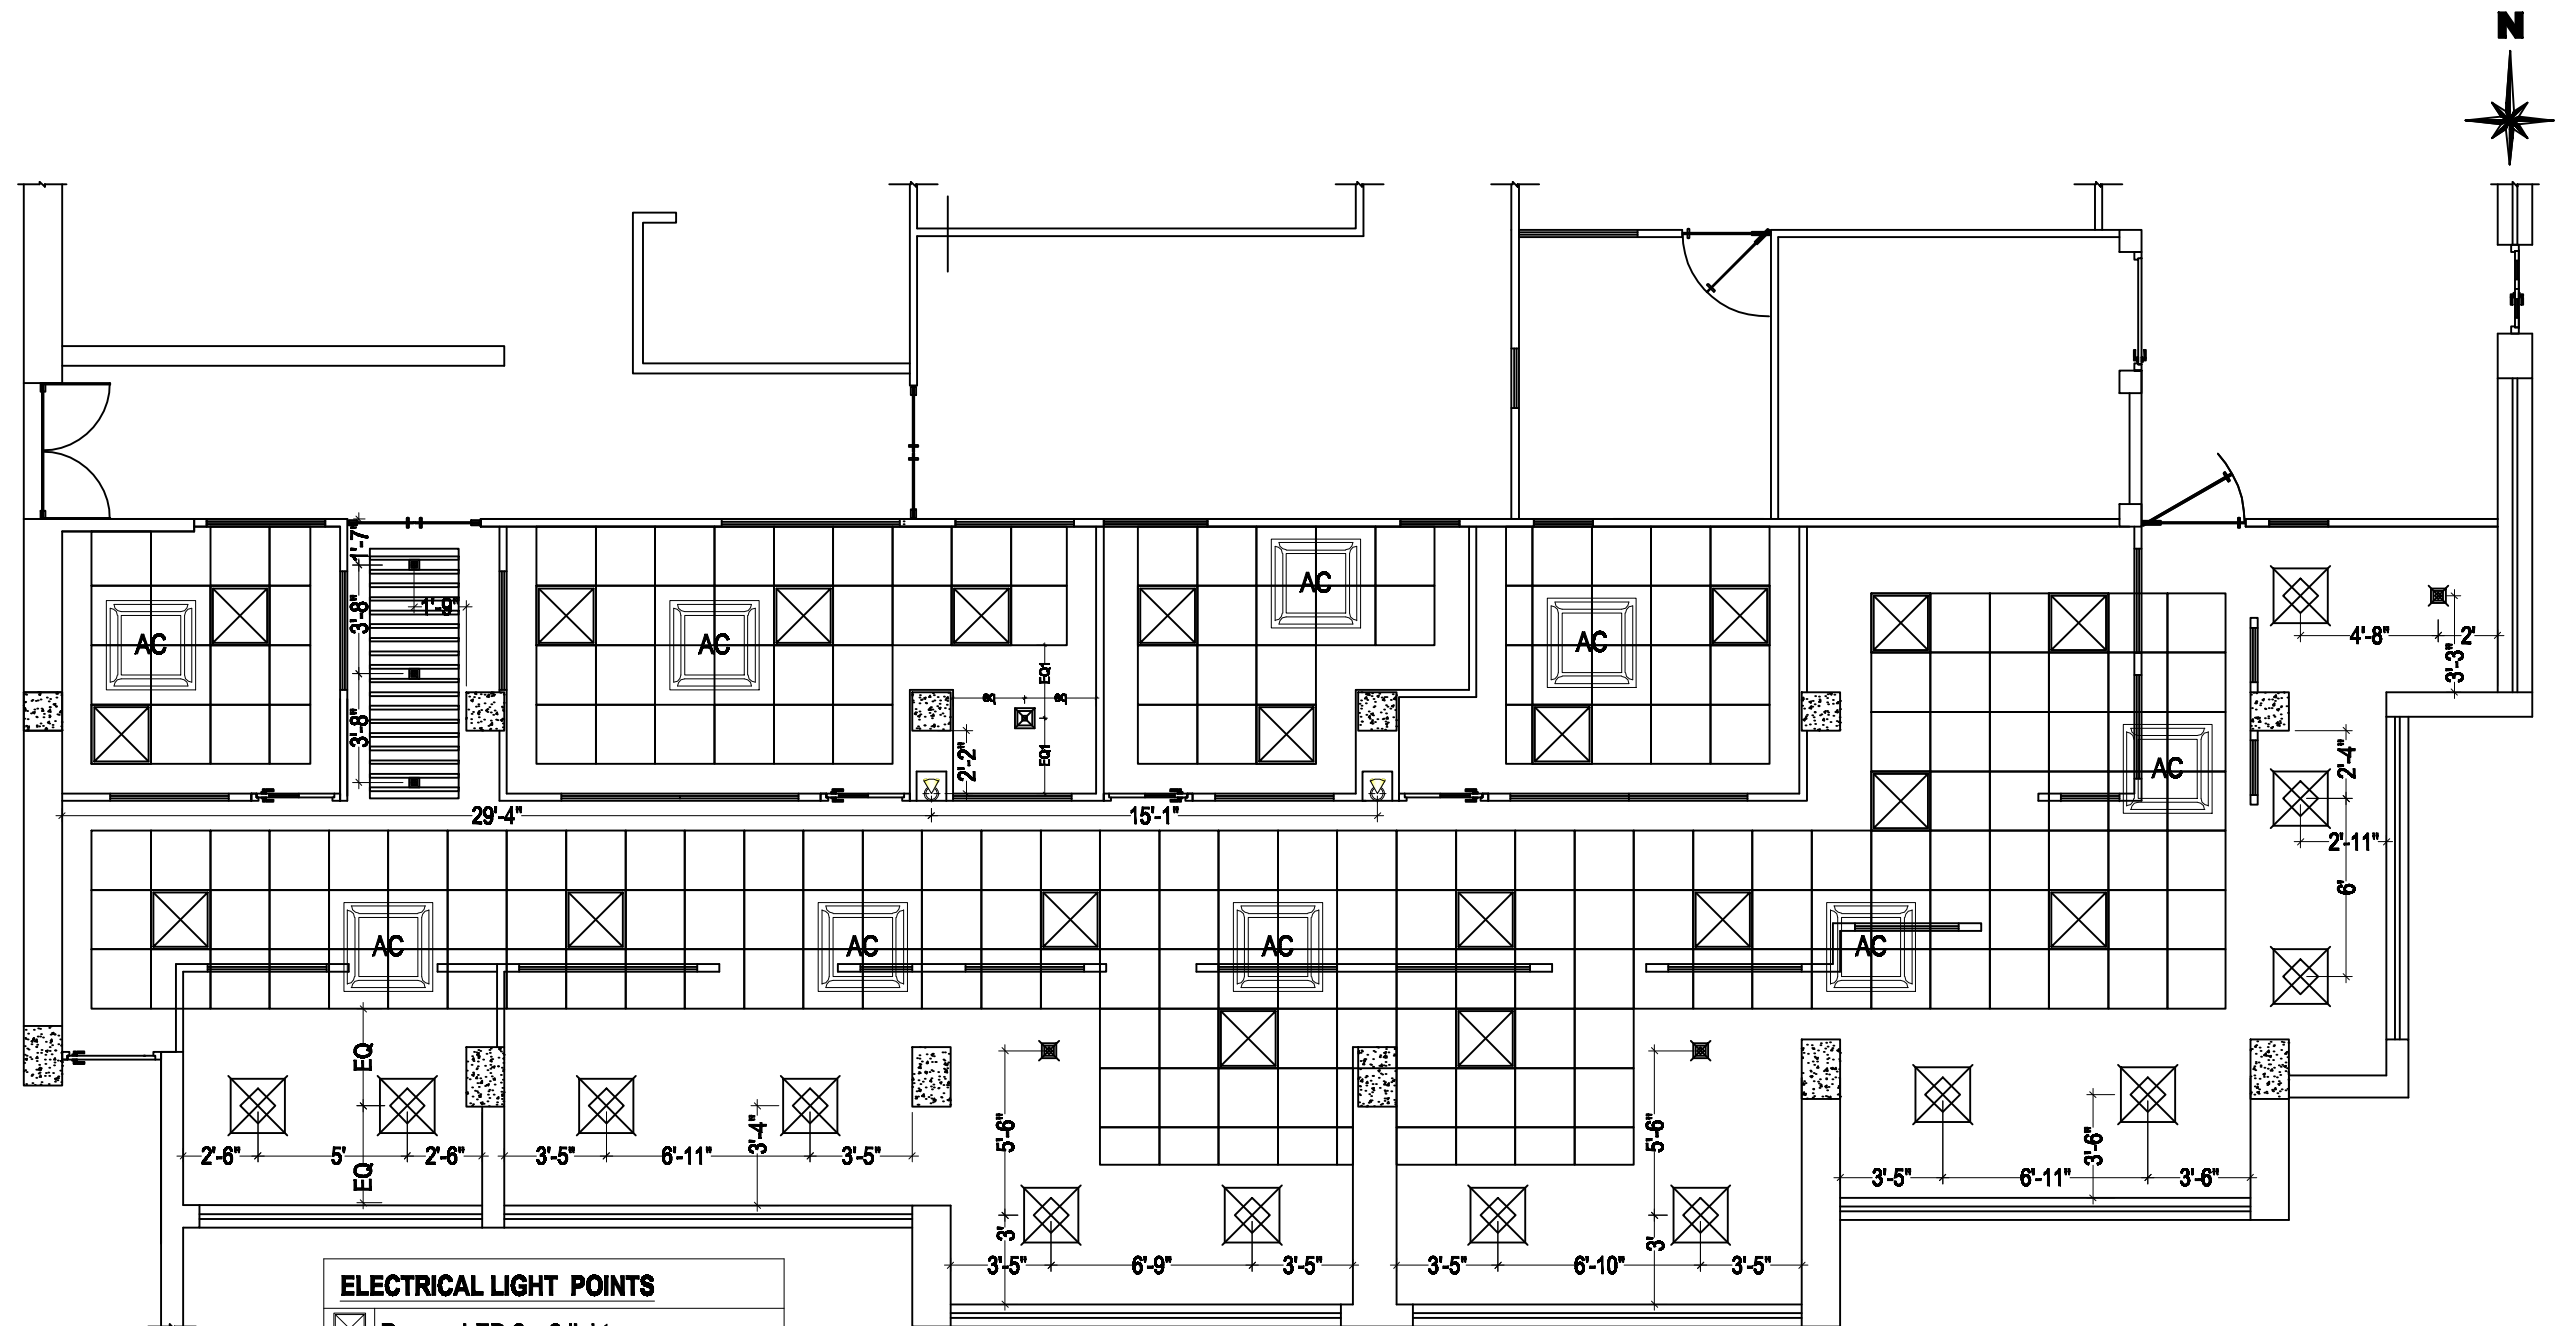

ELECTRICAL LIGHT POINTS	
	Recess LED 2 x 2 light
	Surface LED 2 x 2 light
	Recess 12 watt LED light
	Surface mount 12 watt LED light
	Focus light
	Square Ceiling LED Spotlight

Project:

Resident Co-ordinator's Office
UN Main Building, (SOUTH SIDE) East Wing, Second Floor


ELECTRICAL LIGHT POINT LAYOUT
Second Floor

DESIGN

Date: JULY 2019

Sheet No.:

06

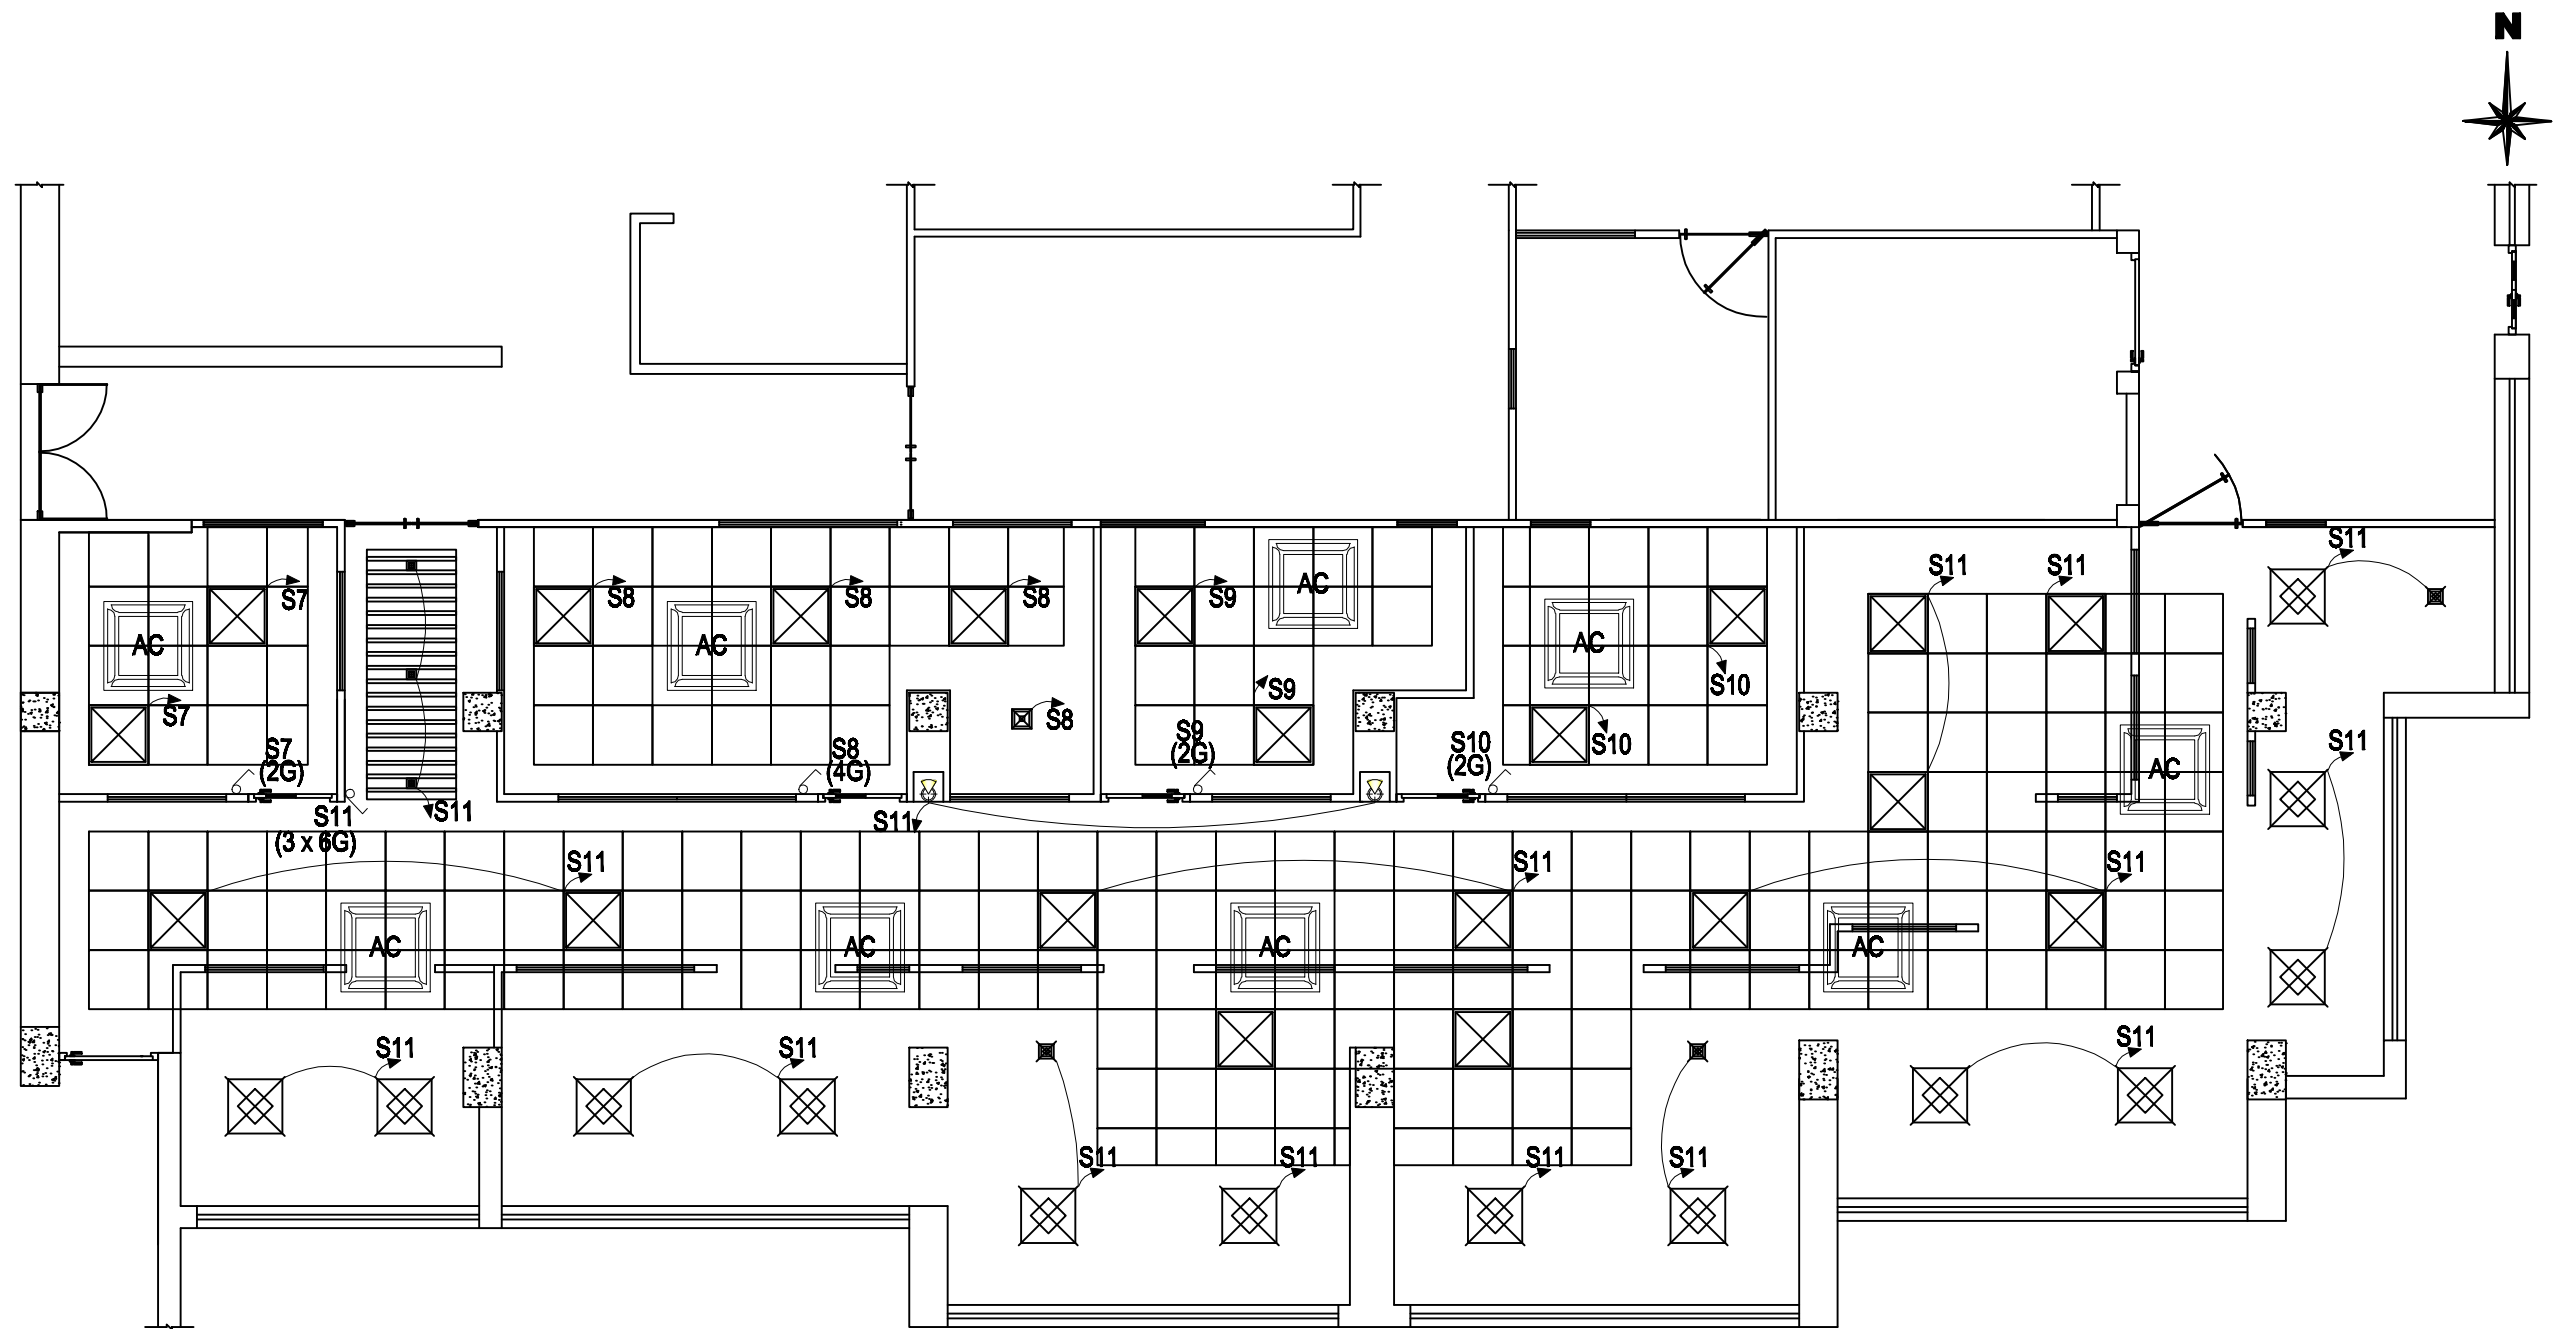

ELECTRICAL SWITCH POINTS	
	Switch
G	Gang
S	Switch Name

Project:

Resident Co-ordinator's Office
UN Main Building, (SOUTH SIDE) East Wing, Second Floor


ELECTRICAL SWITCH LAYOUT
Second Floor

**D
E
S
I
G
N**

Date: JULY 2019

Sheet No.:

07

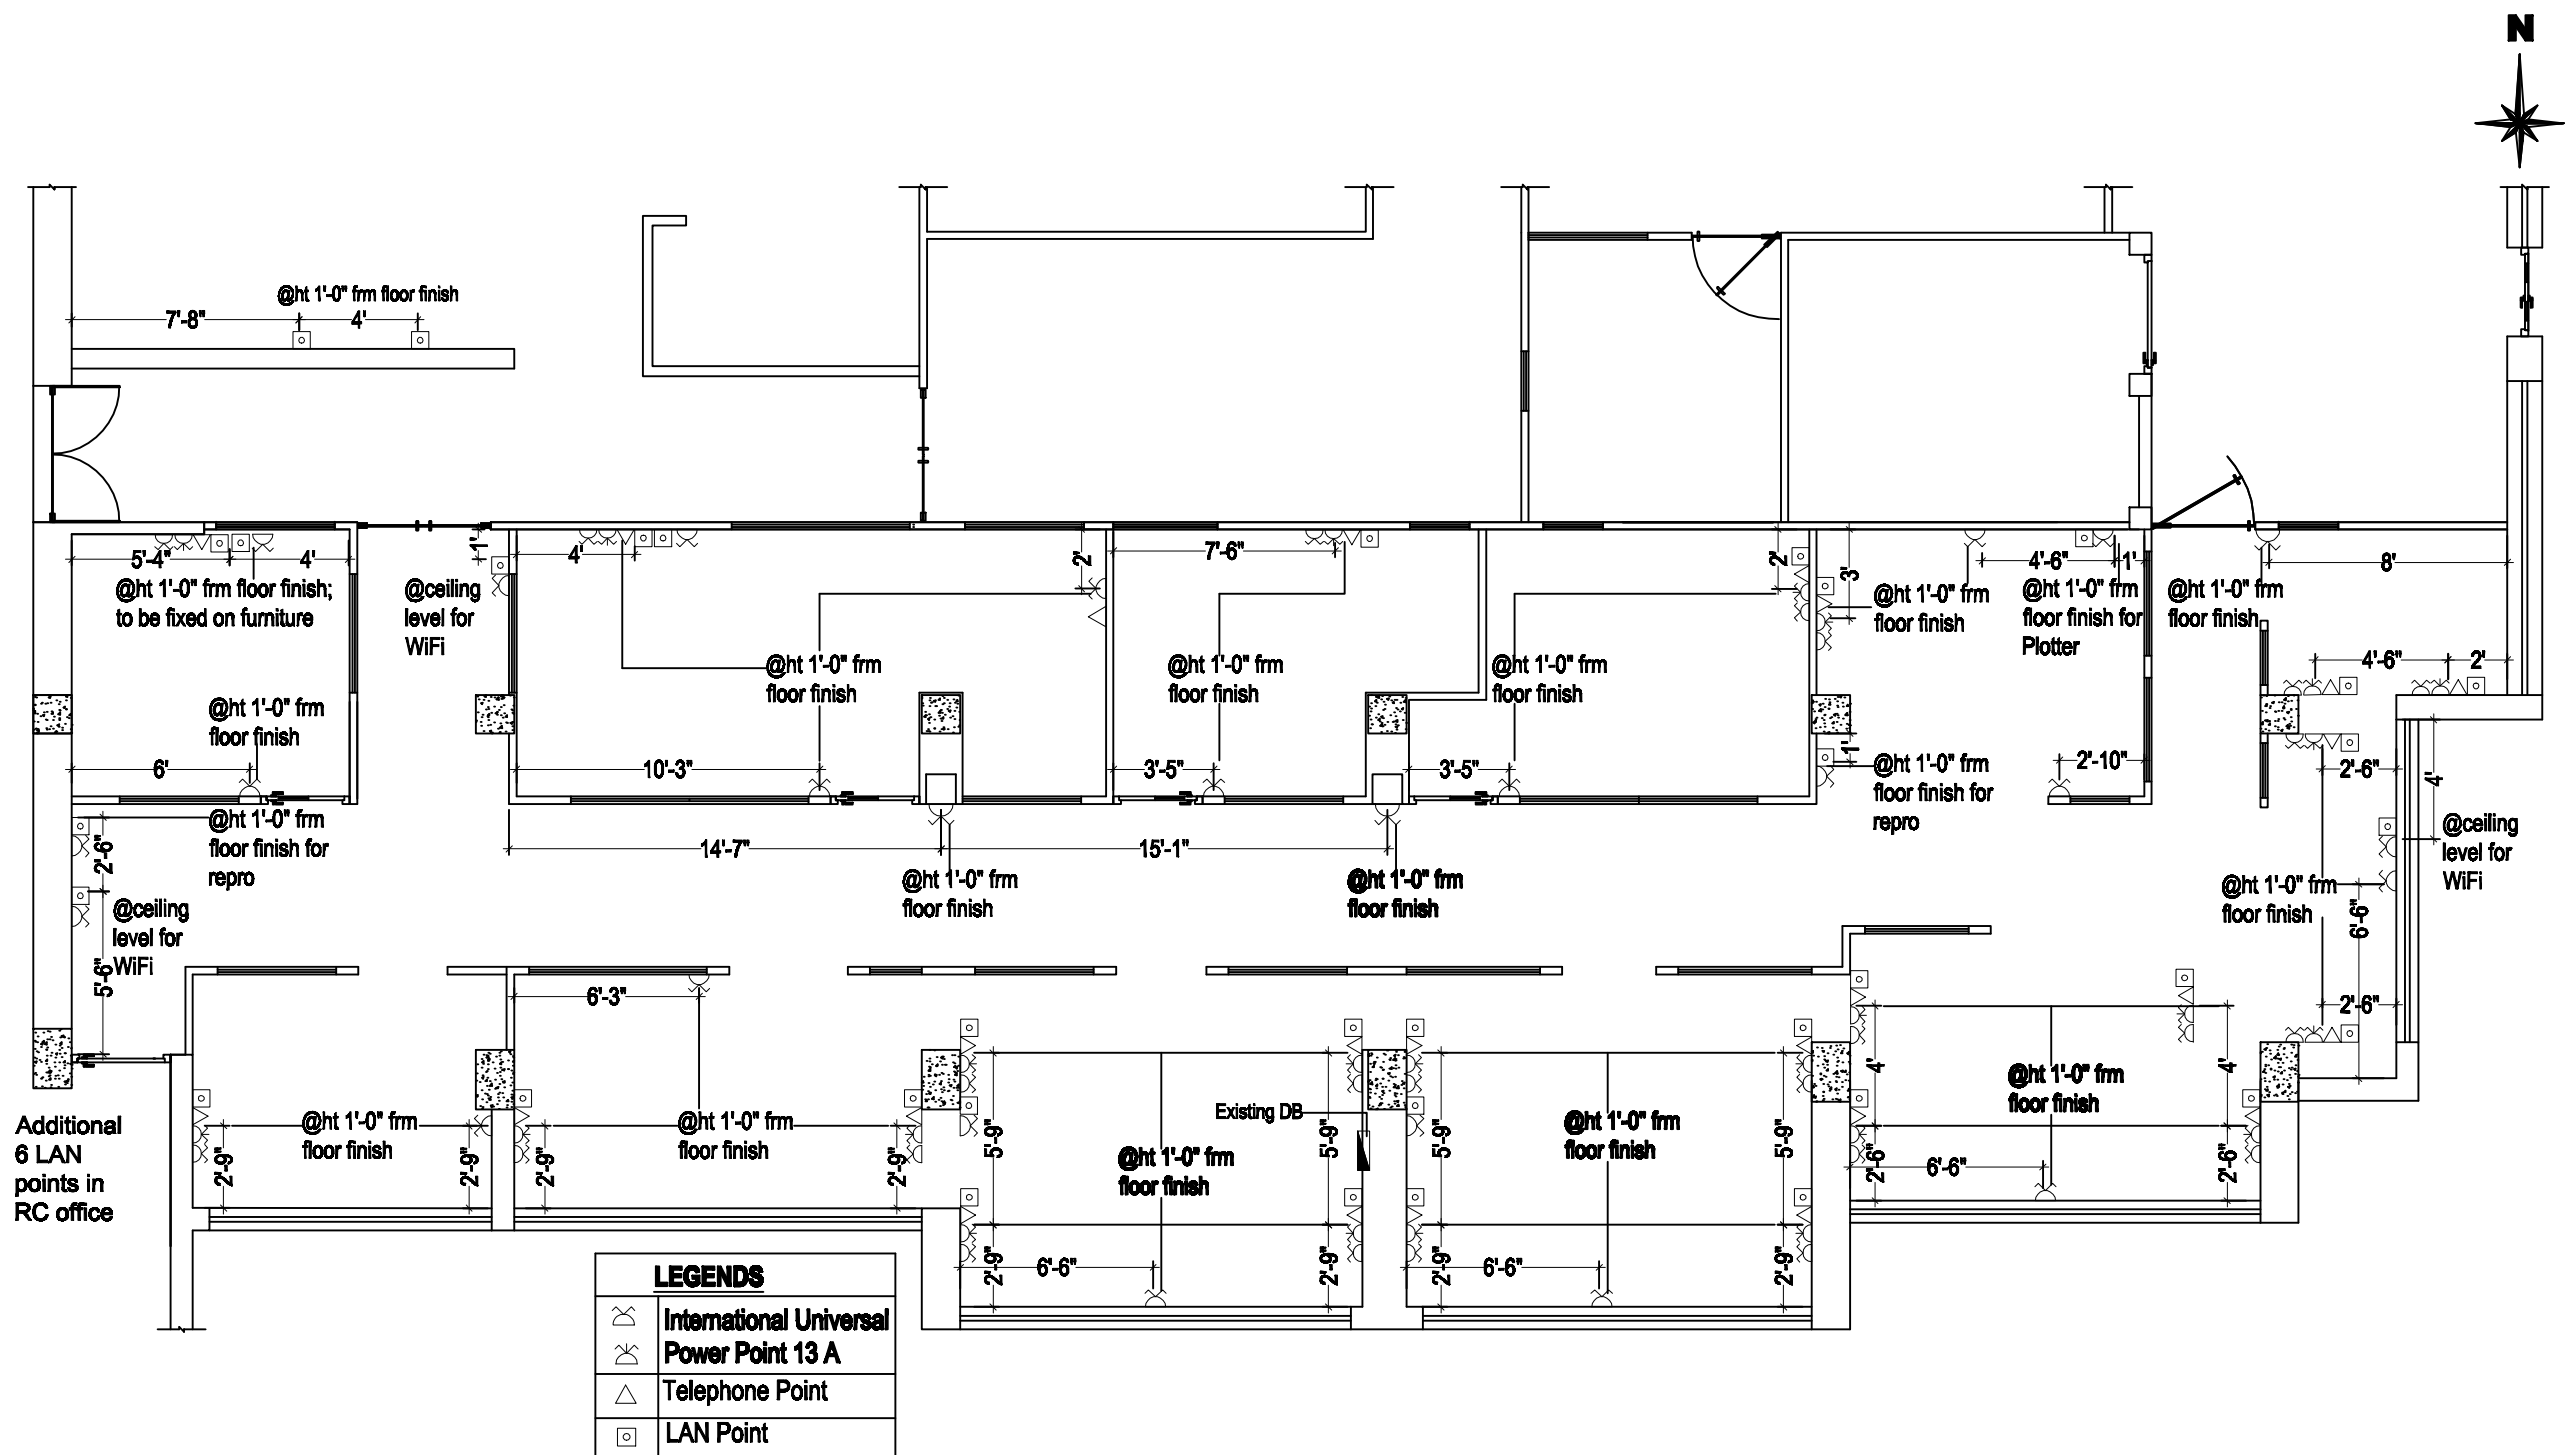

Project:

Resident Co-ordinator's Office
UN Main Building, (SOUTH SIDE) East Wing, Second Floor


ELECTRICAL POWER LAYOUT
Second Floor

DESIGN

Date: JULY 2019

Sheet No.:

08

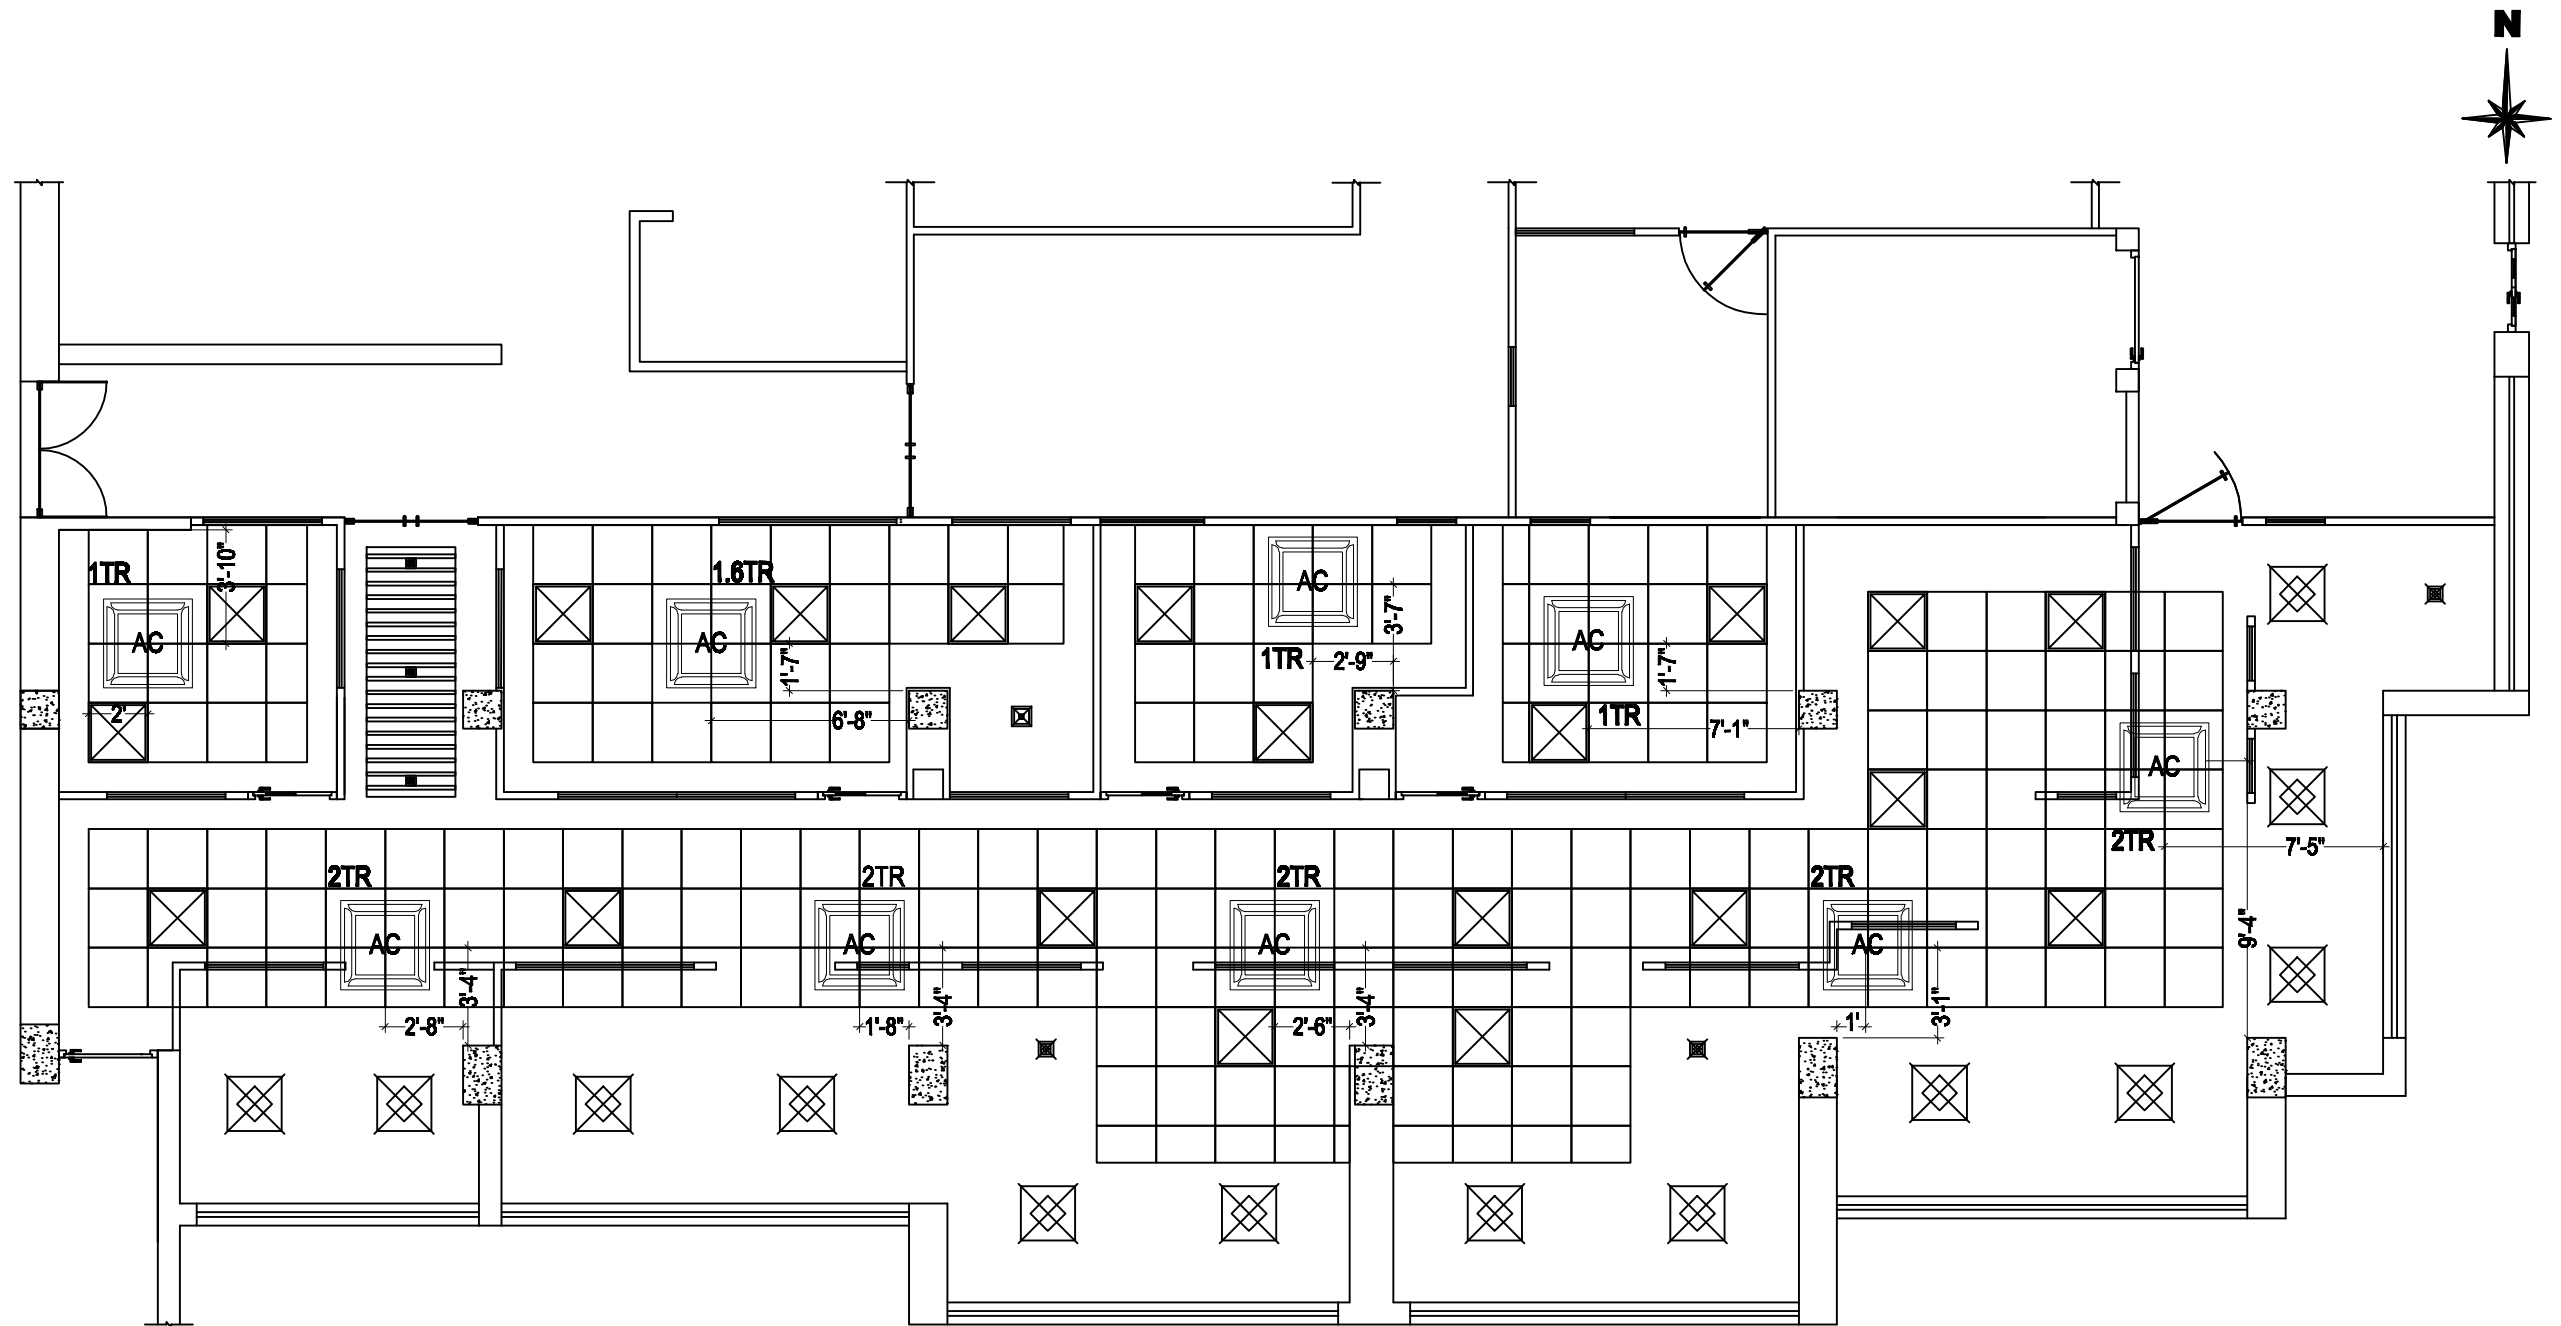

LEGENDS			
	1TR	3Nos.	new units
	1.6TR	1Nos.	new units
Ceiling Unit AC	2TR	5Nos.	new units

AC OUTDOOR UNITS PLACED ON THIRD FLOOR TERRACE

Project:

Resident Co-ordinator's Office
UN Main Building, (SOUTH SIDE) East Wing, Second Floor


HVAC LAYOUT
Second Floor


D
E
S
I
G
N

Date: JULY 2019


Sheet No.:

09

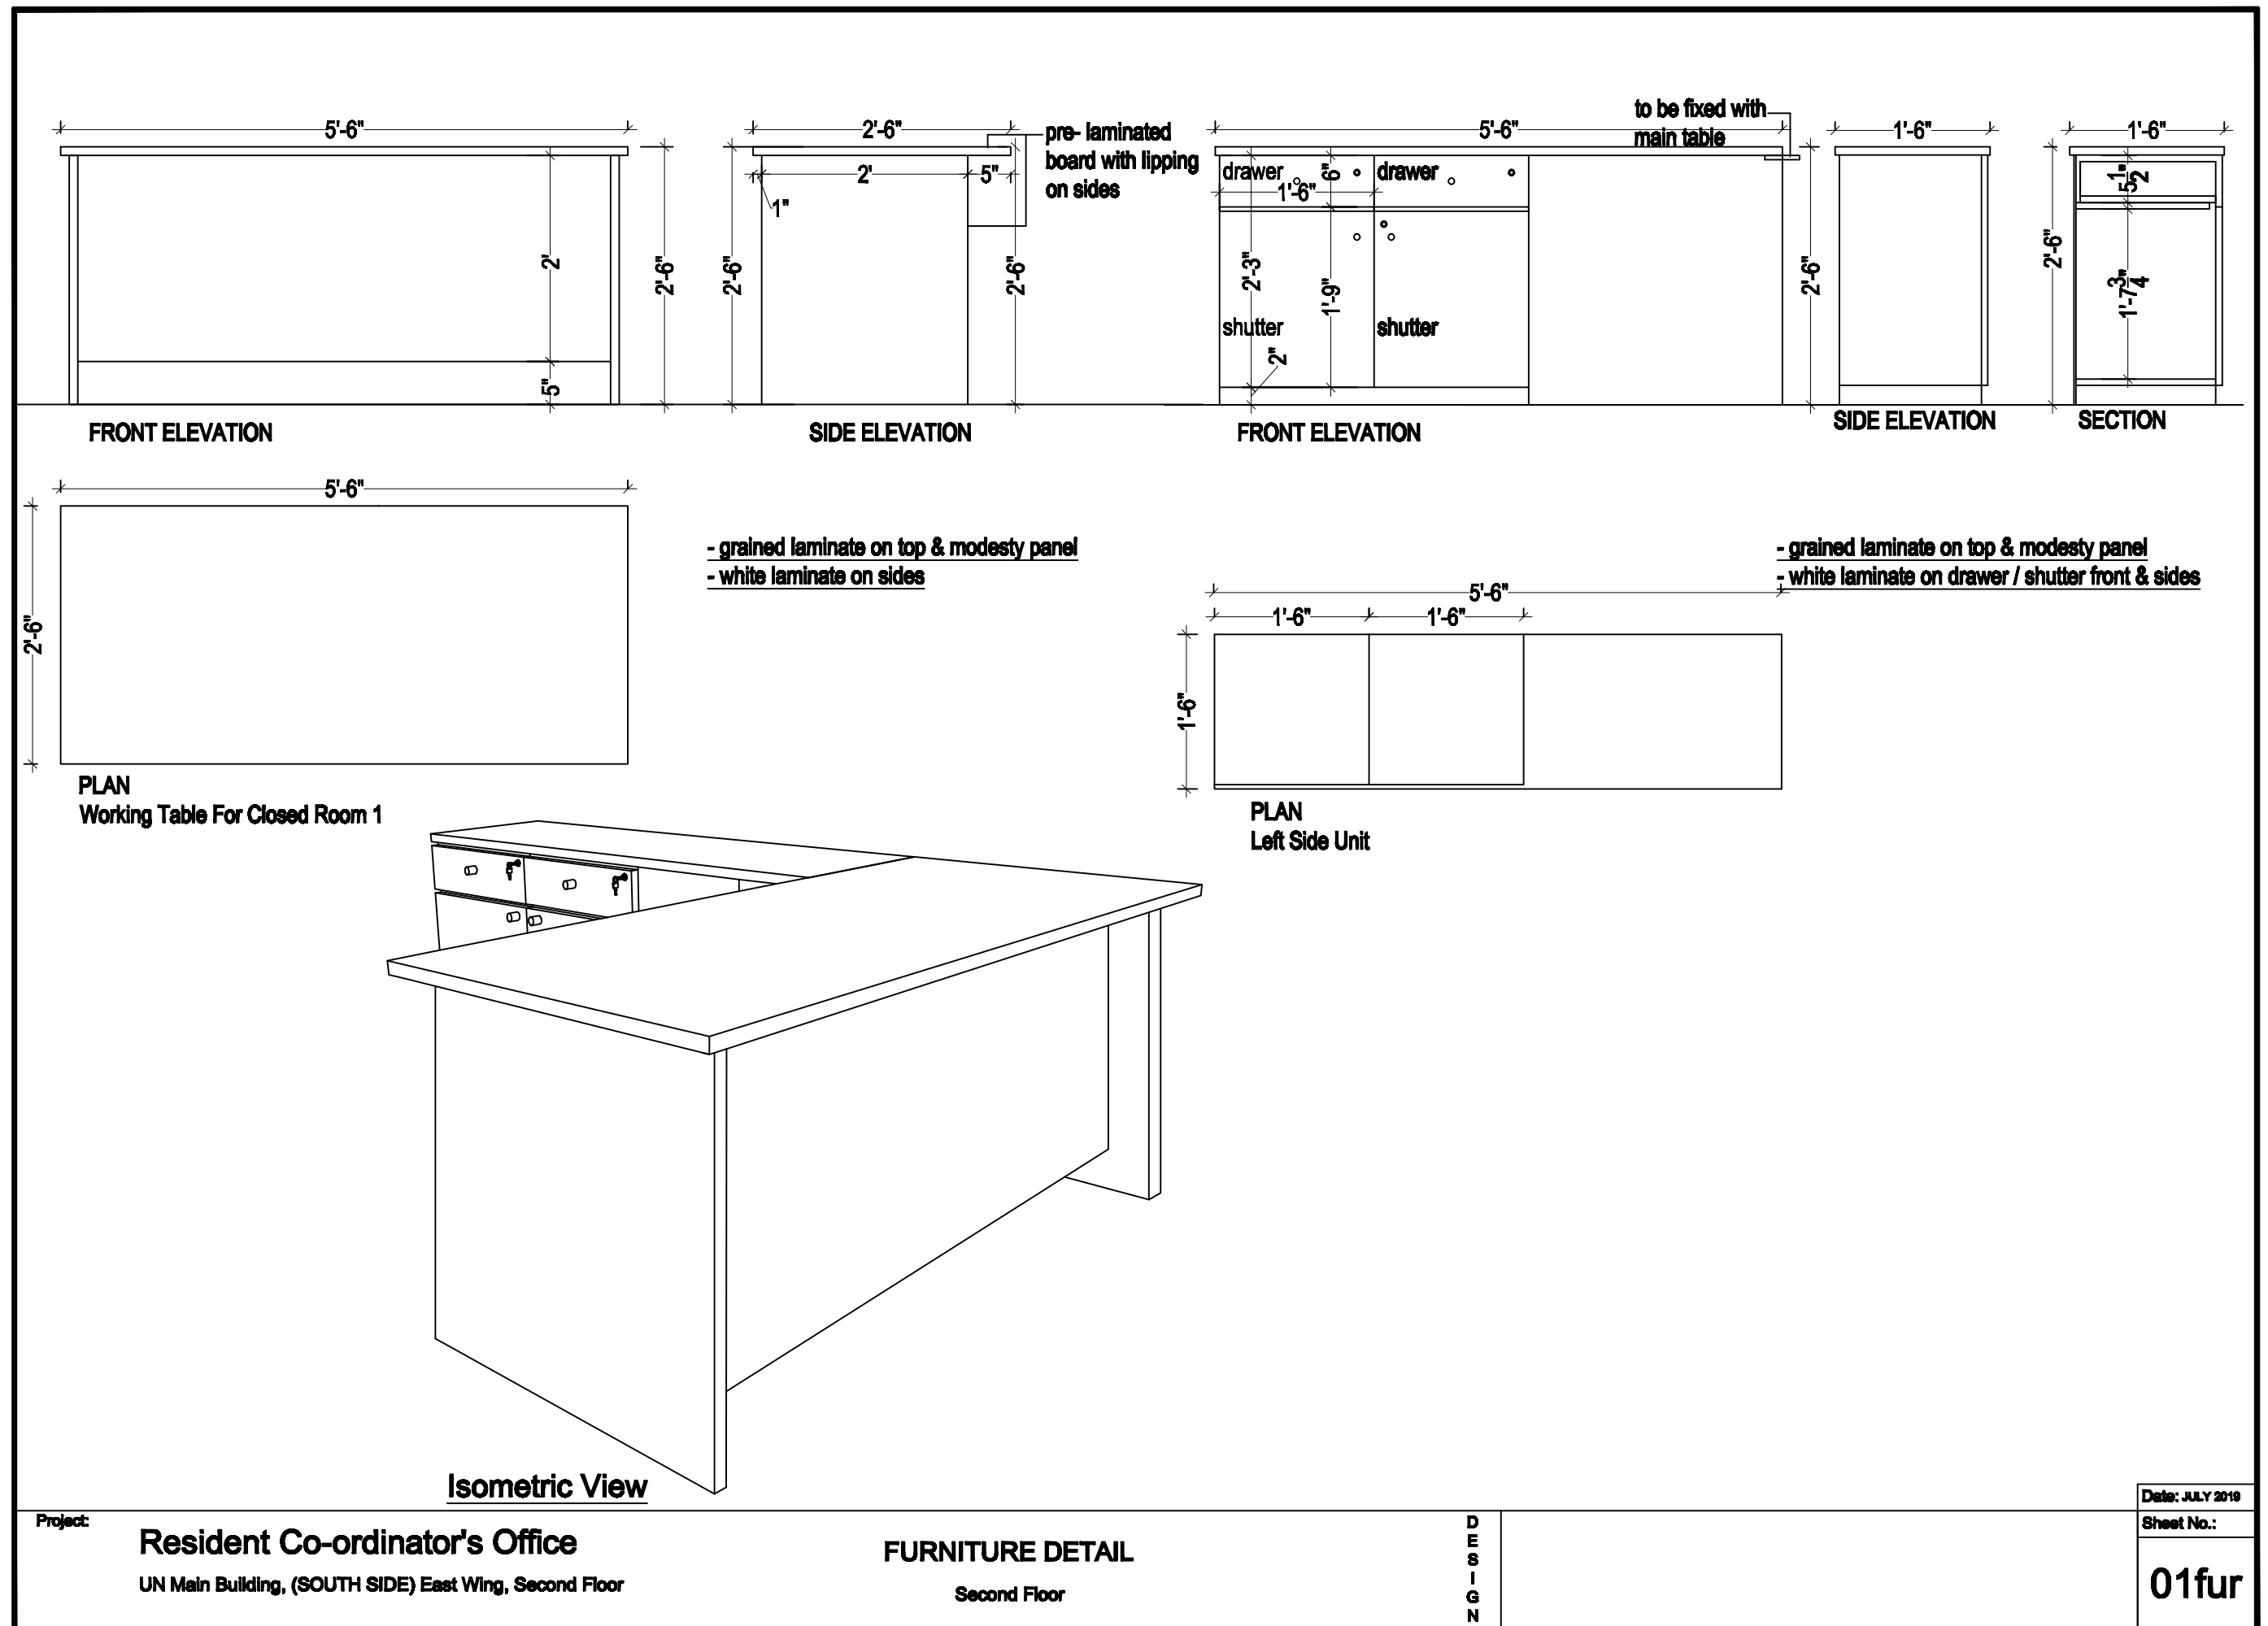


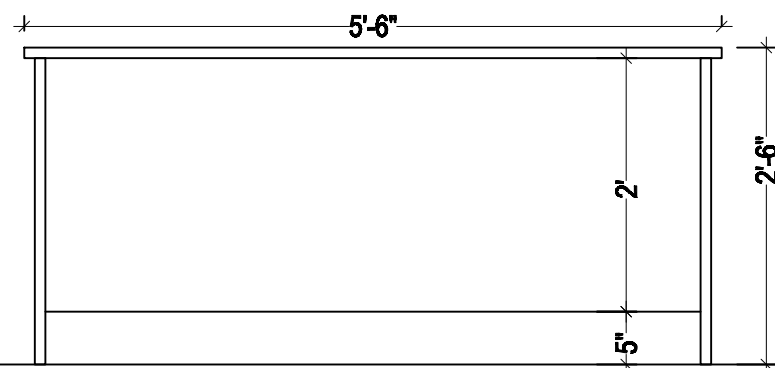


FRONT ELEVATION

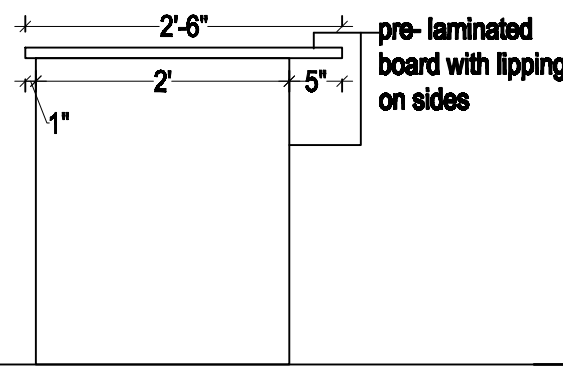


SIDE ELEVATION

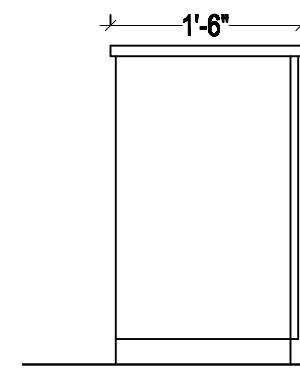


SIDE ELEVATION

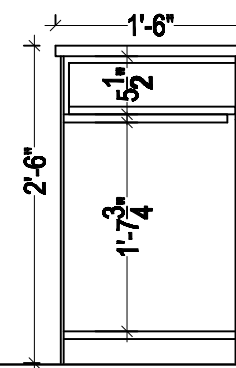

SECTION

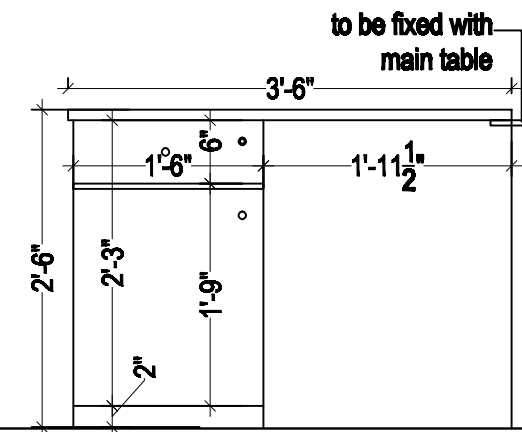


FRONT ELEVATION

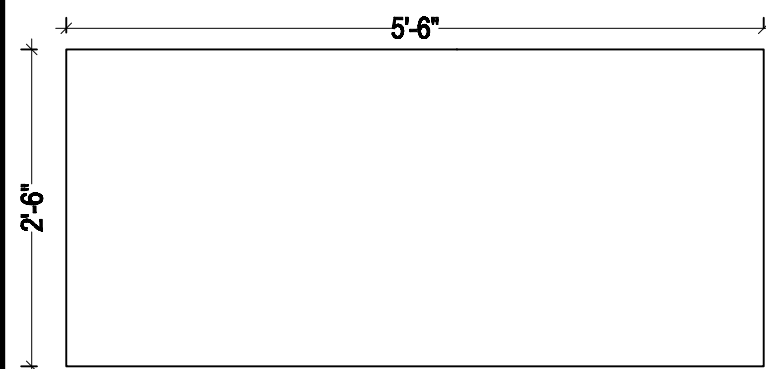

PLAN

Executive Working Table For Closed Room 4

- grained laminate on top & modesty panel
- white laminate on sides

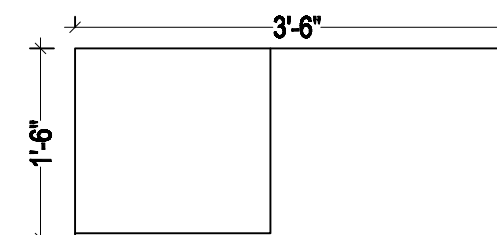


PLAN

Left Side Unit

- grained laminate on top & modesty panel
- white laminate on drawer / shutter front & sides

Isometric View

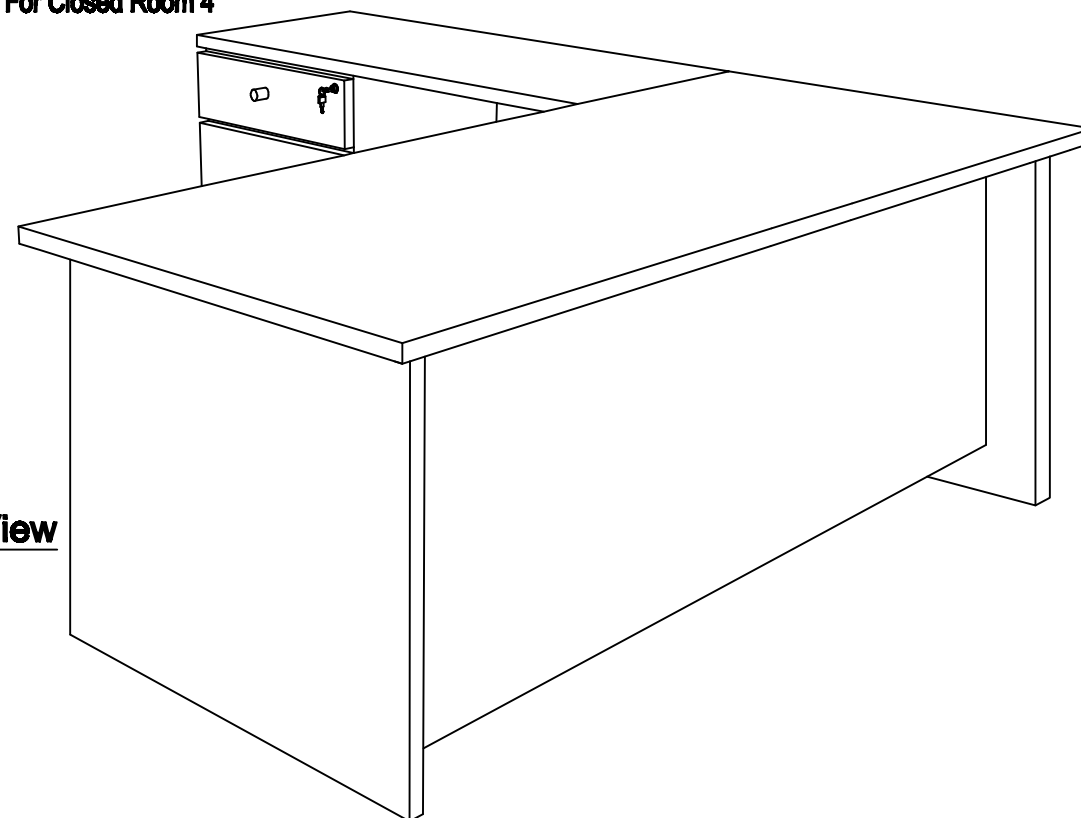

Project:

Resident Co-ordinator's Office

UN Main Building, (SOUTH SIDE) East Wing, Second Floor

FURNITURE DETAIL


Second Floor

D
E
S
I
G
N


Date: JULY 2019

Sheet No.:


03fur

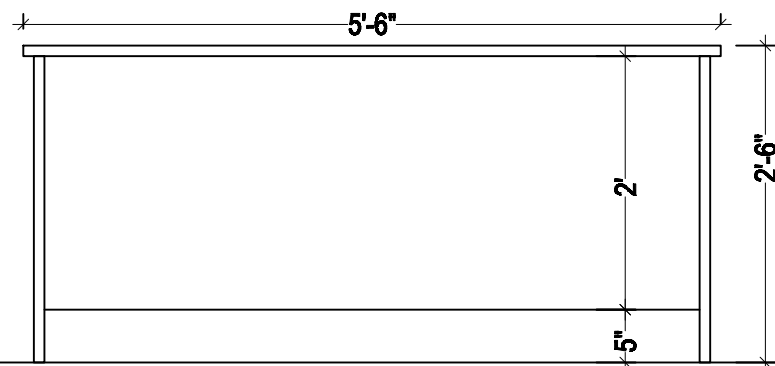


FRONT ELEVATION

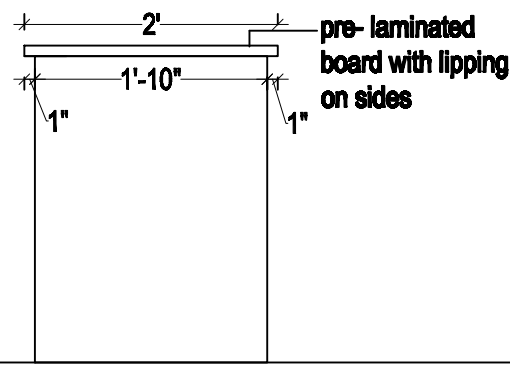


SIDE ELEVATION

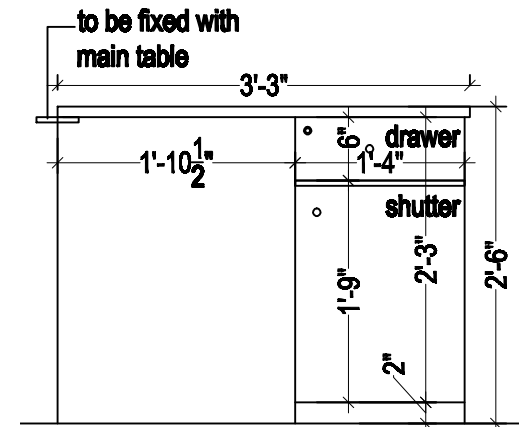

FRONT ELEVATION

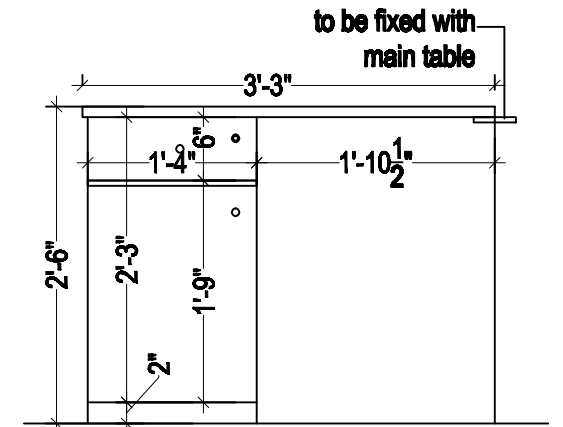


FRONT ELEVATION

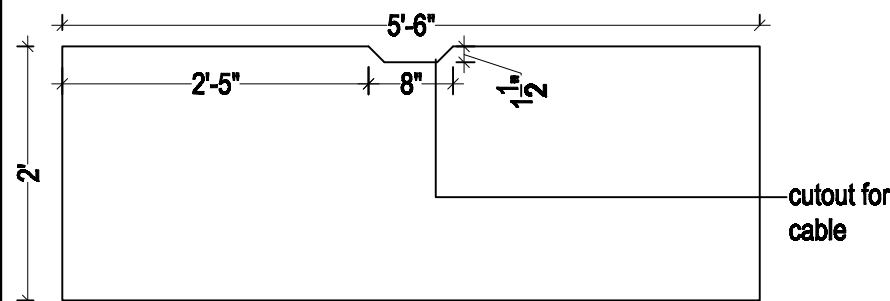


PLAN
Staff Working Table


- grained laminate on top & modesty panel
- white laminate on sides

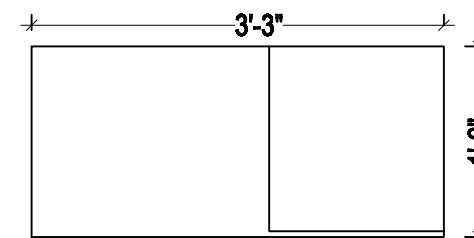


PLAN
Right Side Unit

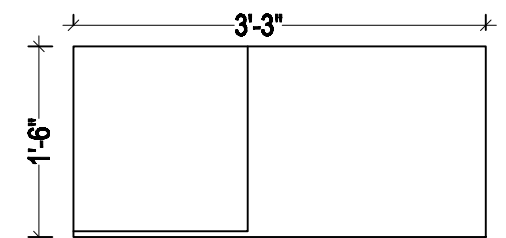

PLAN
Left Side Unit

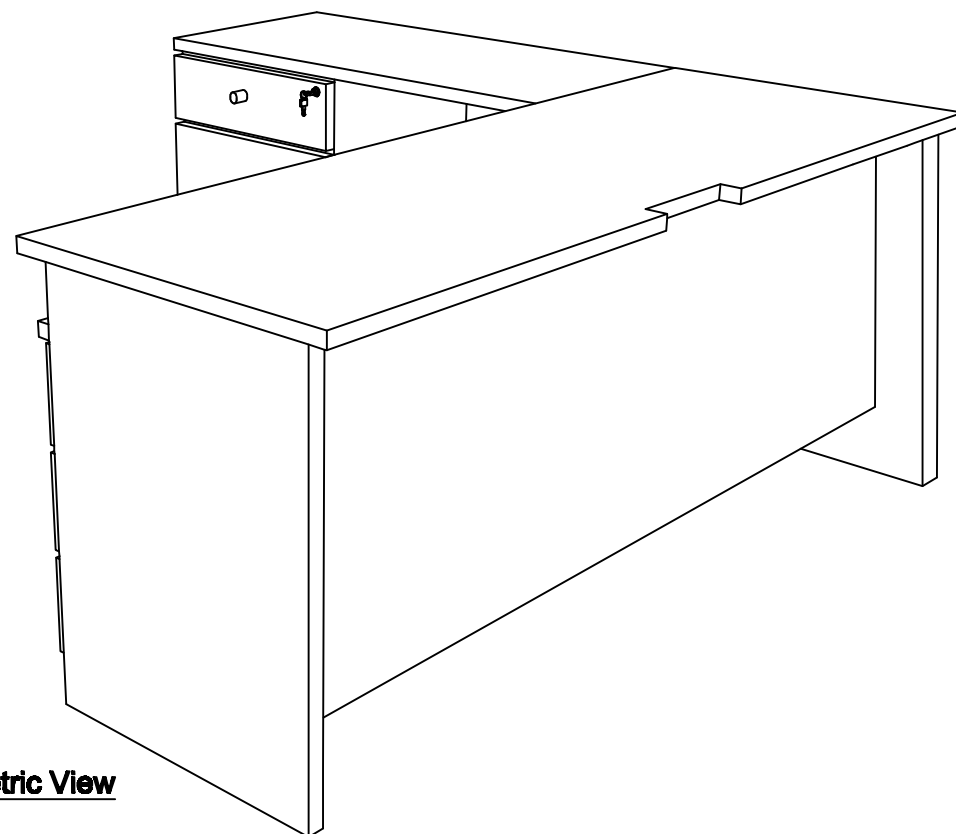

Isometric View

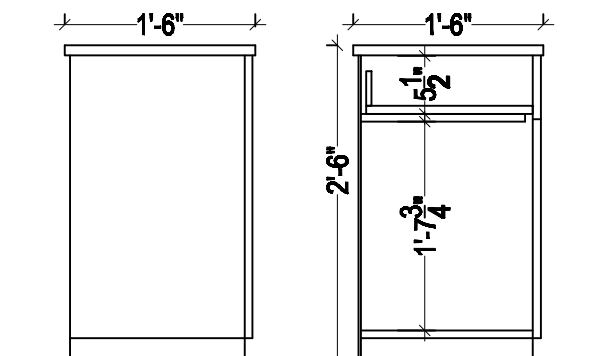

SIDE ELEVATION

SECTION

Project:

Resident Co-ordinator's Office
UN Main Building, (SOUTH SIDE) East Wing, Second Floor

FURNITURE DETAIL


Second Floor

D
E
S
I
G
N


Date: JULY 2019

Sheet No.:


04fur

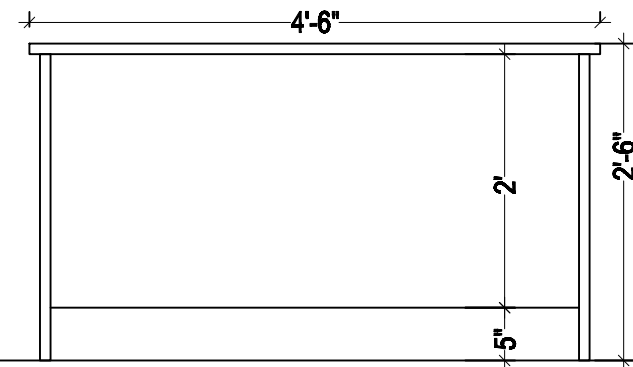


FRONT ELEVATION

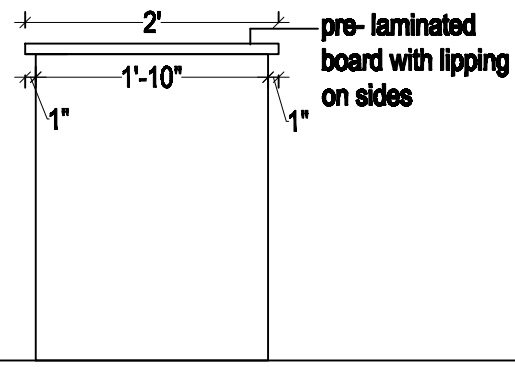


SIDE ELEVATION

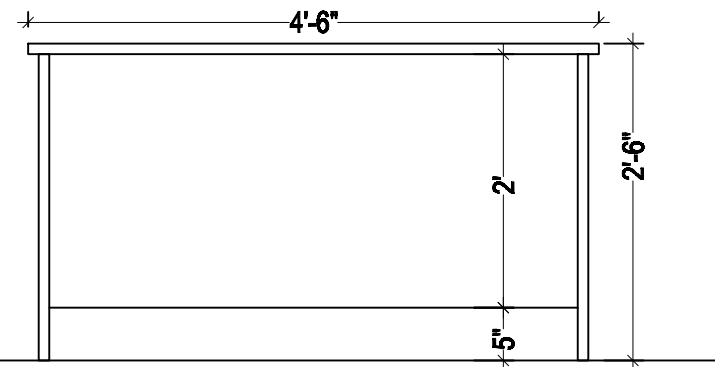

REAR ELEVATION

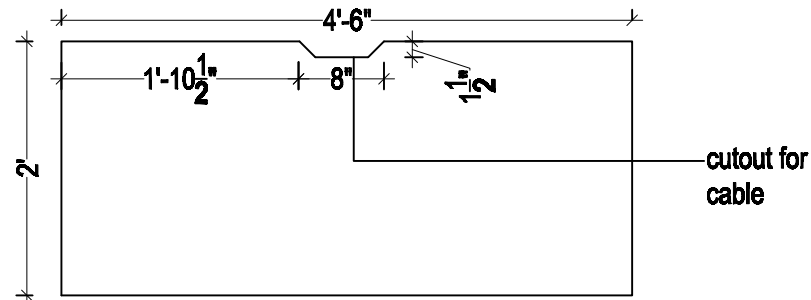

PLAN
Staff Working Table

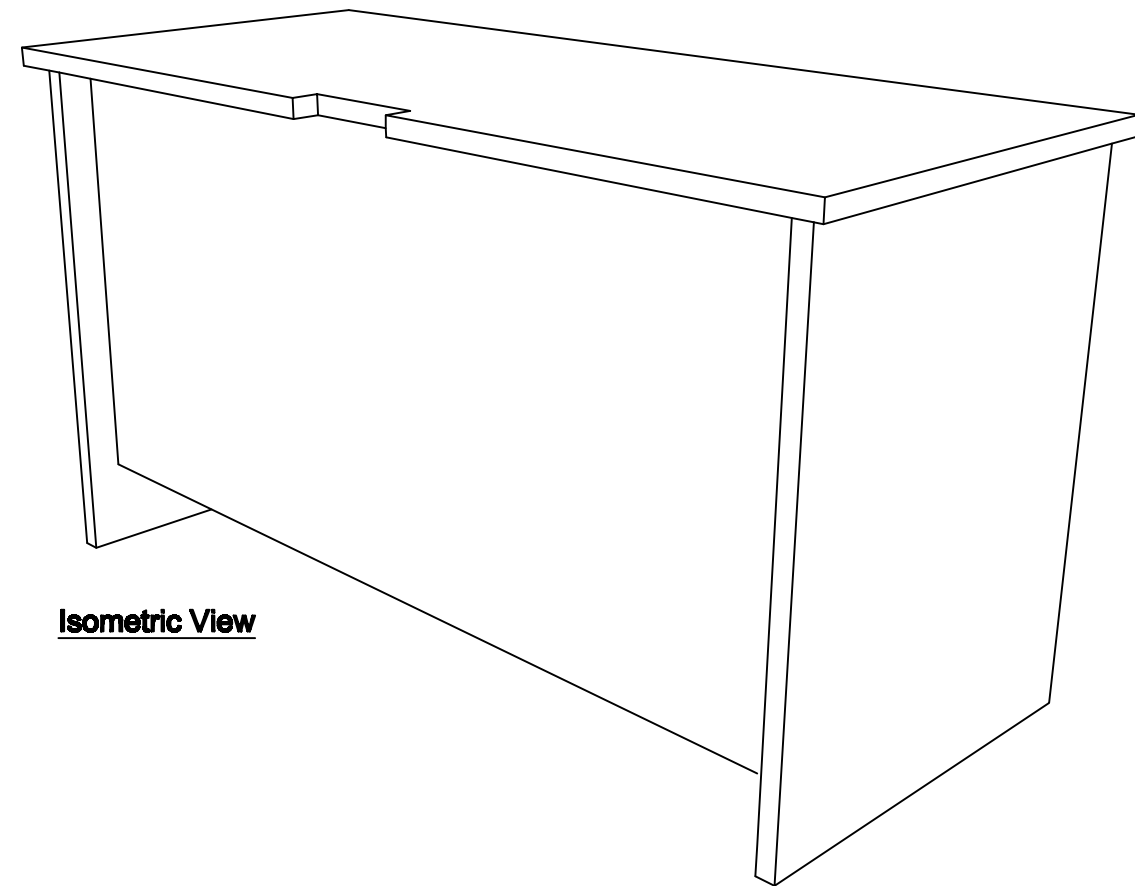

Isometric View

Project:

Resident Co-ordinator's Office
UN Main Building, (SOUTH SIDE) East Wing, Second Floor


FURNITURE DETAIL
Second Floor

**D
E
S
I
G
N**

Date: JULY 2019

Sheet No.:


05fur

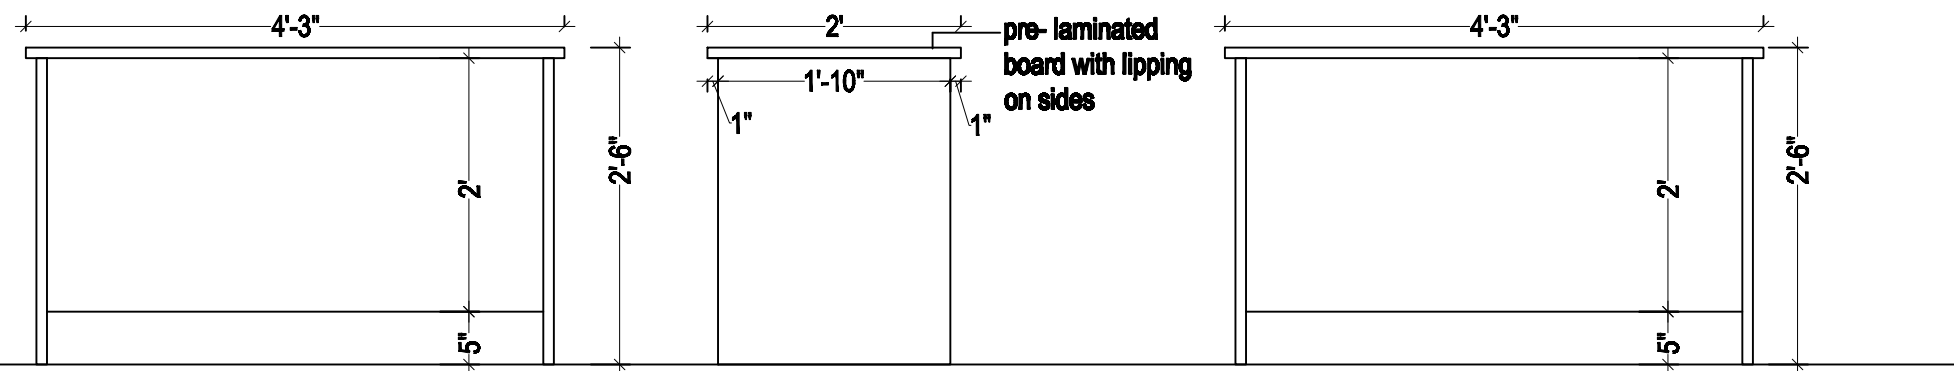


FRONT ELEVATION

SIDE ELEVATION


REAR ELEVATION

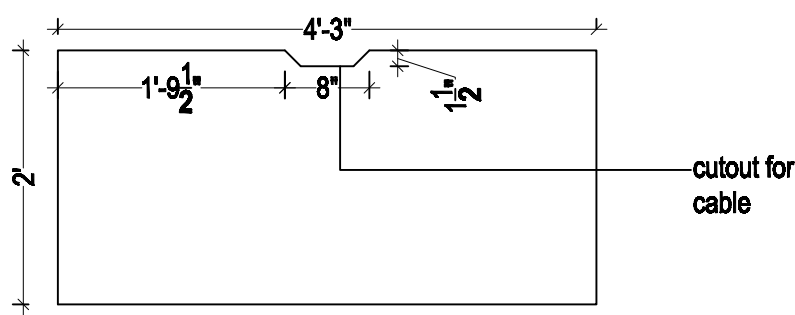


PLAN
Staff Working Table

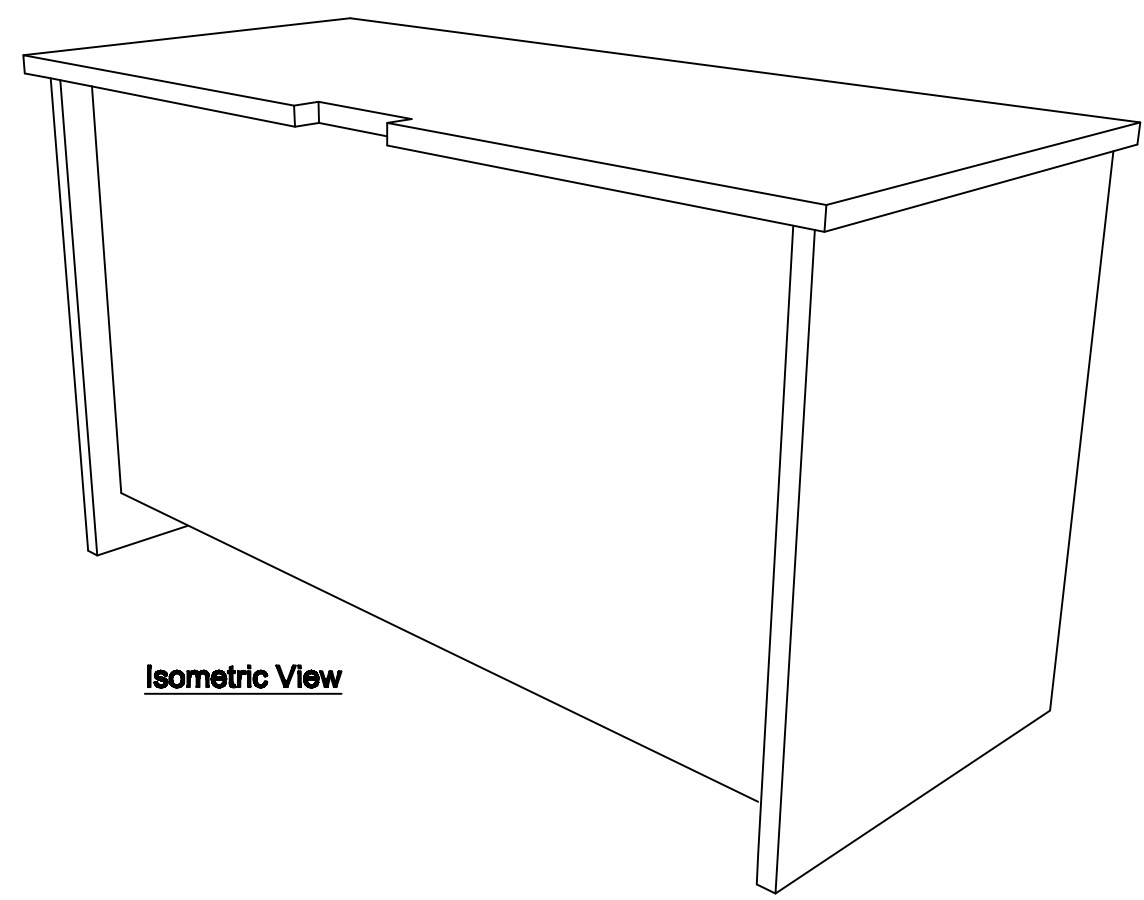


Isometric View

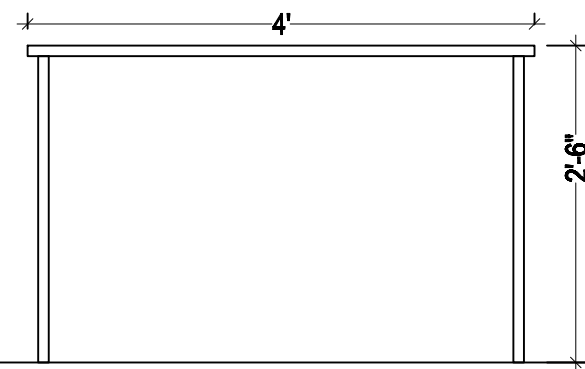


FRONT ELEVATION

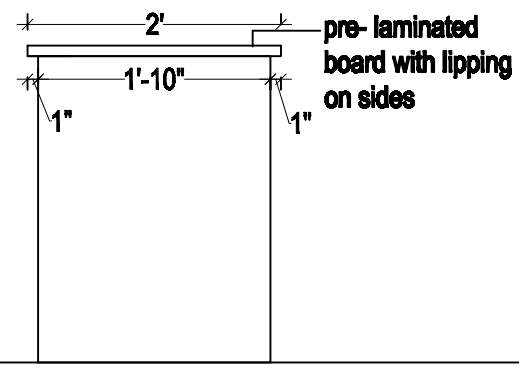

SIDE ELEVATION

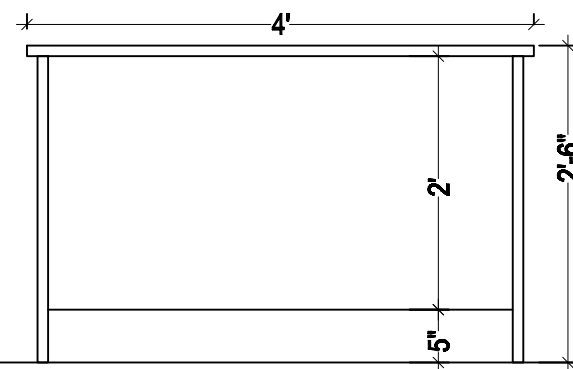


REAR ELEVATION

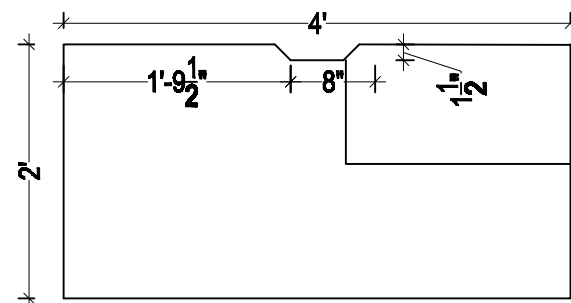

PLAN
Staff Working Table

cutout for
cable

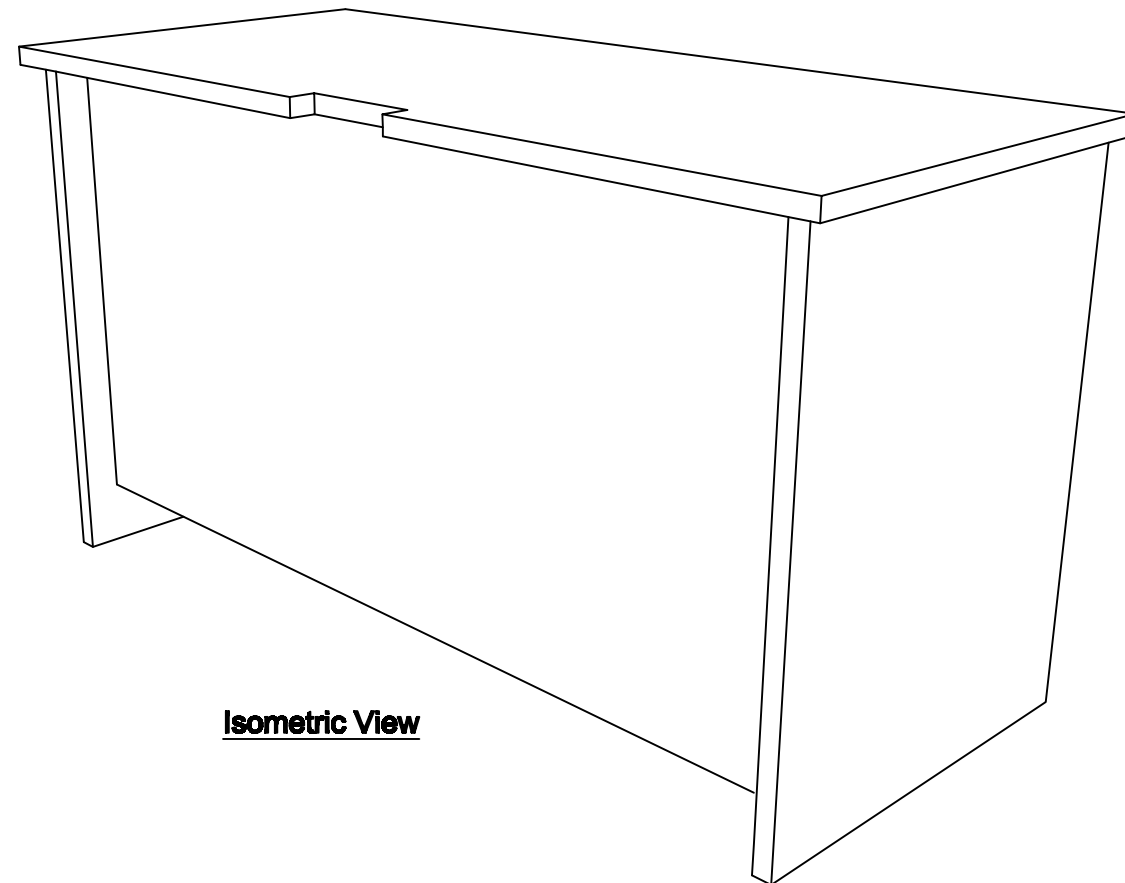

Isometric View

Project:

Resident Co-ordinator's Office
UN Main Building, (SOUTH SIDE) East Wing, Second Floor


FURNITURE DETAIL
Second Floor

D
E
S
I
G
N

Date: JULY 2019

Sheet No.:

07fur

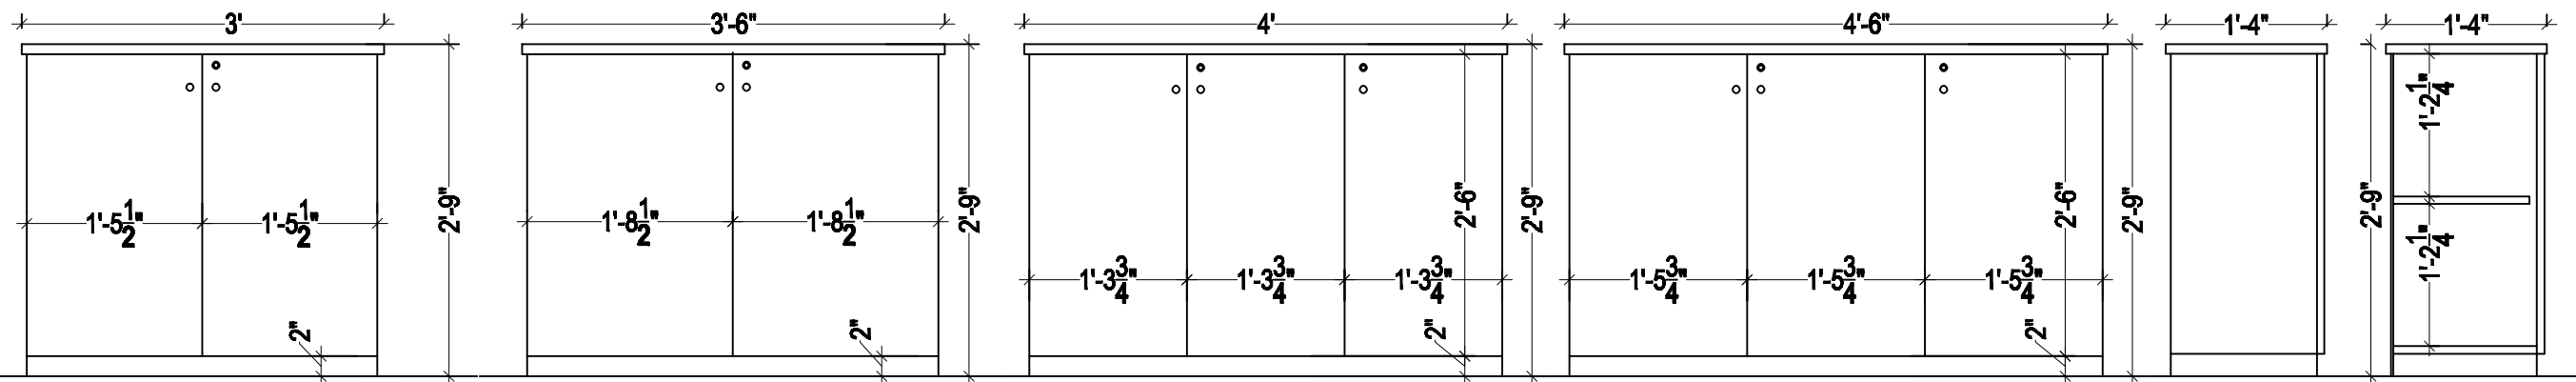

FRONT ELEVATION


FRONT ELEVATION

FRONT ELEVATION


FRONT ELEVATION

SIDE ELEVATION


SECTION

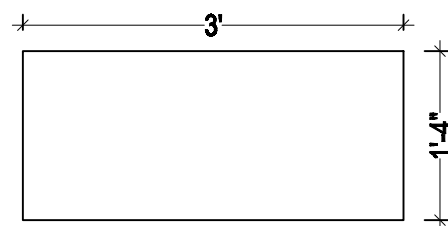


PLAN
Filing Cabinet FC1

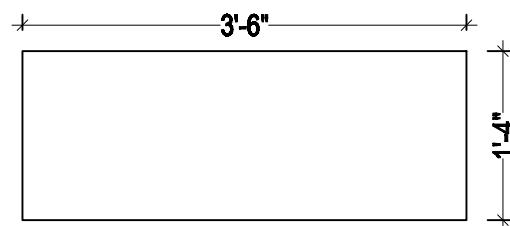

PLAN
Filing Cabinet FC3

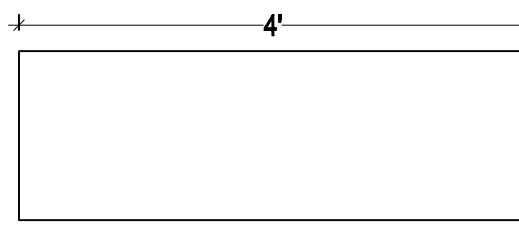


PLAN
Filing Cabinet FC4

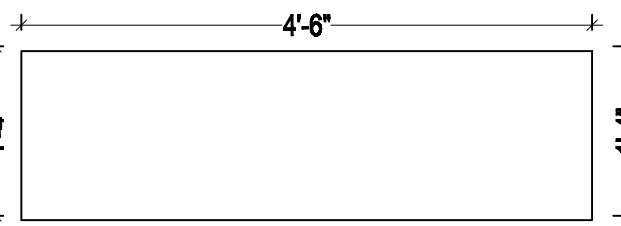


PLAN
Filing Cabinet FC5

- grained laminate on top & front panel / shutters
- white laminate on sides

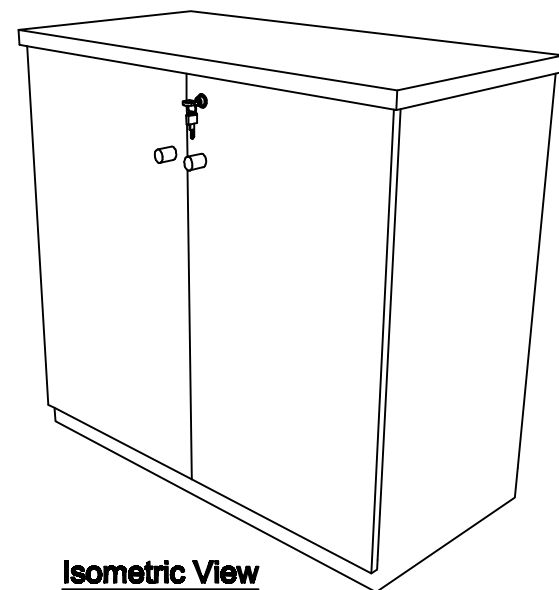

Isometric View

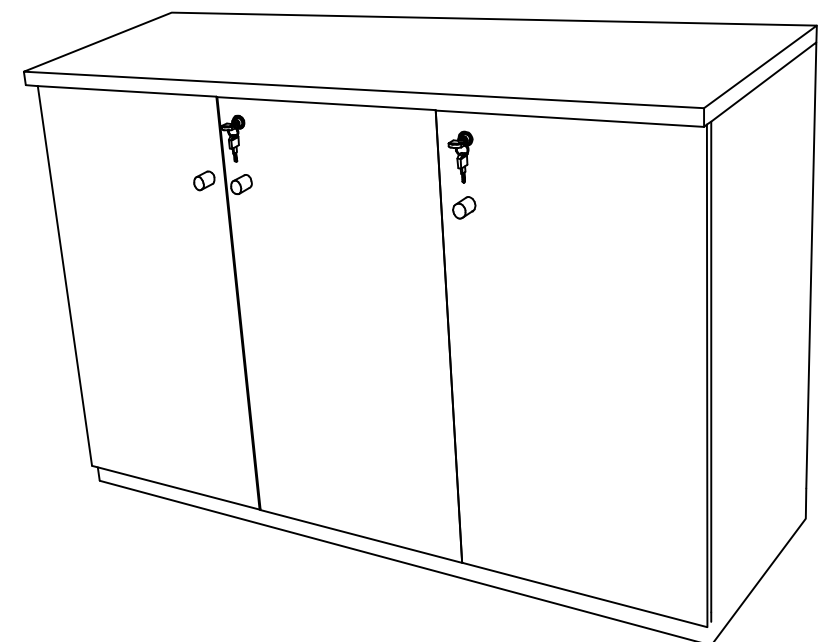

Isometric View

Project:

Resident Co-ordinator's Office
UN Main Building, (SOUTH SIDE) East Wing, Second Floor



FURNITURE DETAIL
Second Floor

DESIGN

Date: JULY 2019




Sheet No.:

08fur

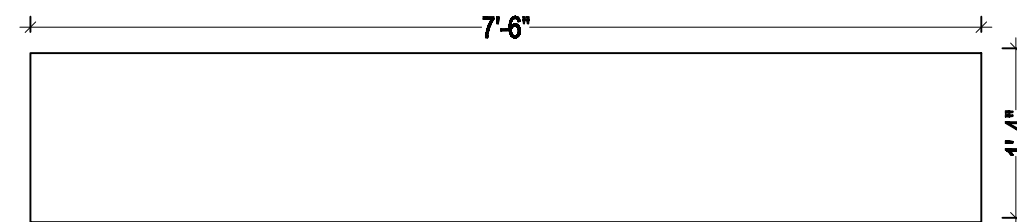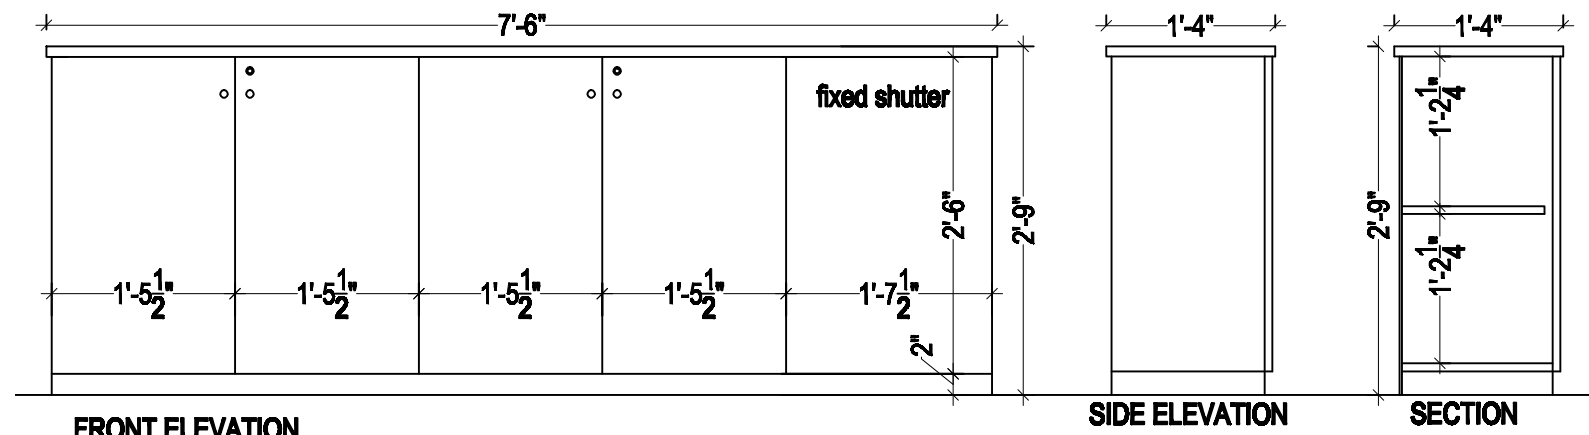


PLAN
Filing Cabinet FC8

- grained laminate on top & front panel / shutters
- white laminate on sides

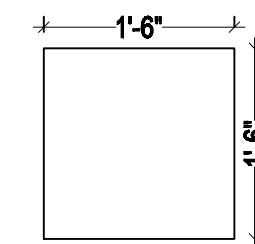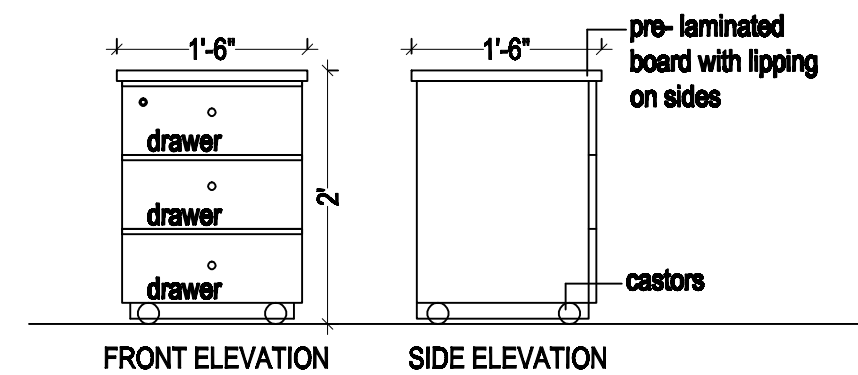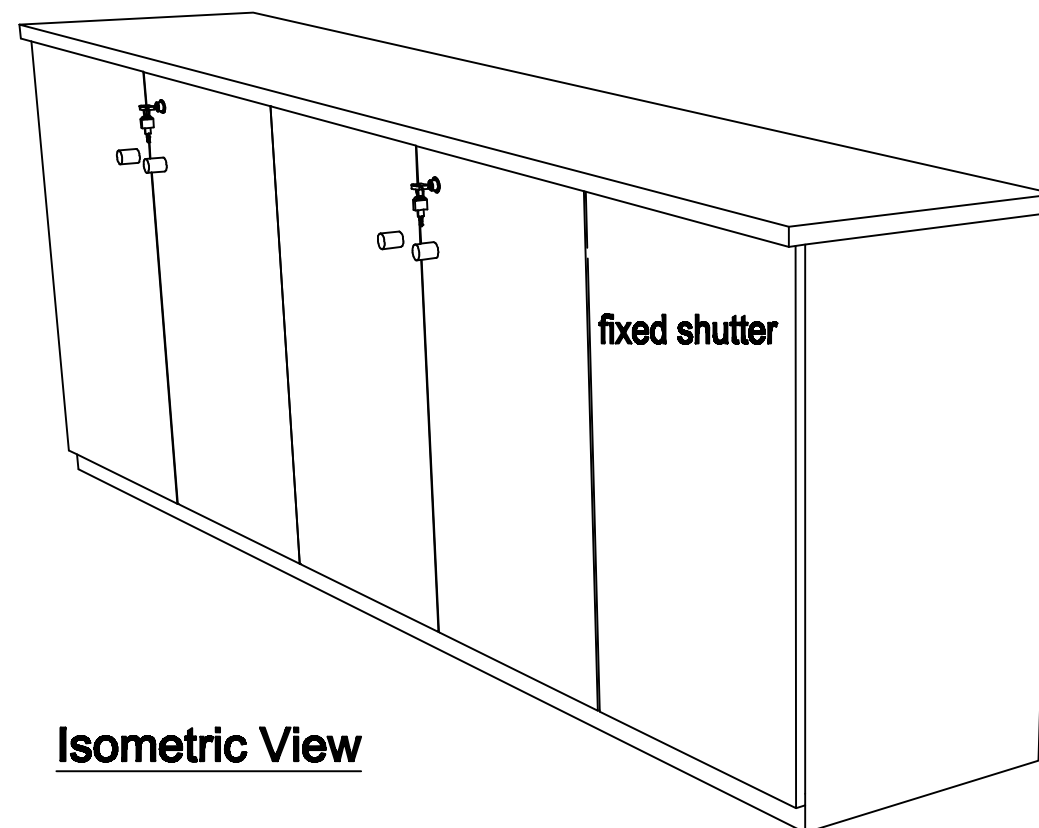

Plan
Pedestal Drawer

- grained laminate on top & front panel / drawers
- white laminate on sides
- white laminate on sides

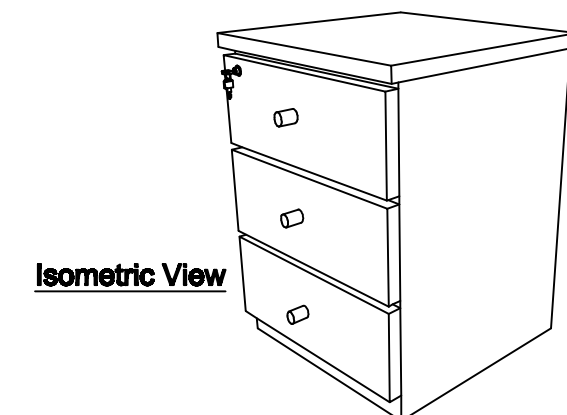

Project:

Resident Co-ordinator's Office
UN Main Building, (SOUTH SIDE) East Wing, Second Floor


FURNITURE DETAIL
Second Floor

**D
E
S
I
G
N**

Date: JULY 2019

Sheet No.:

09fur

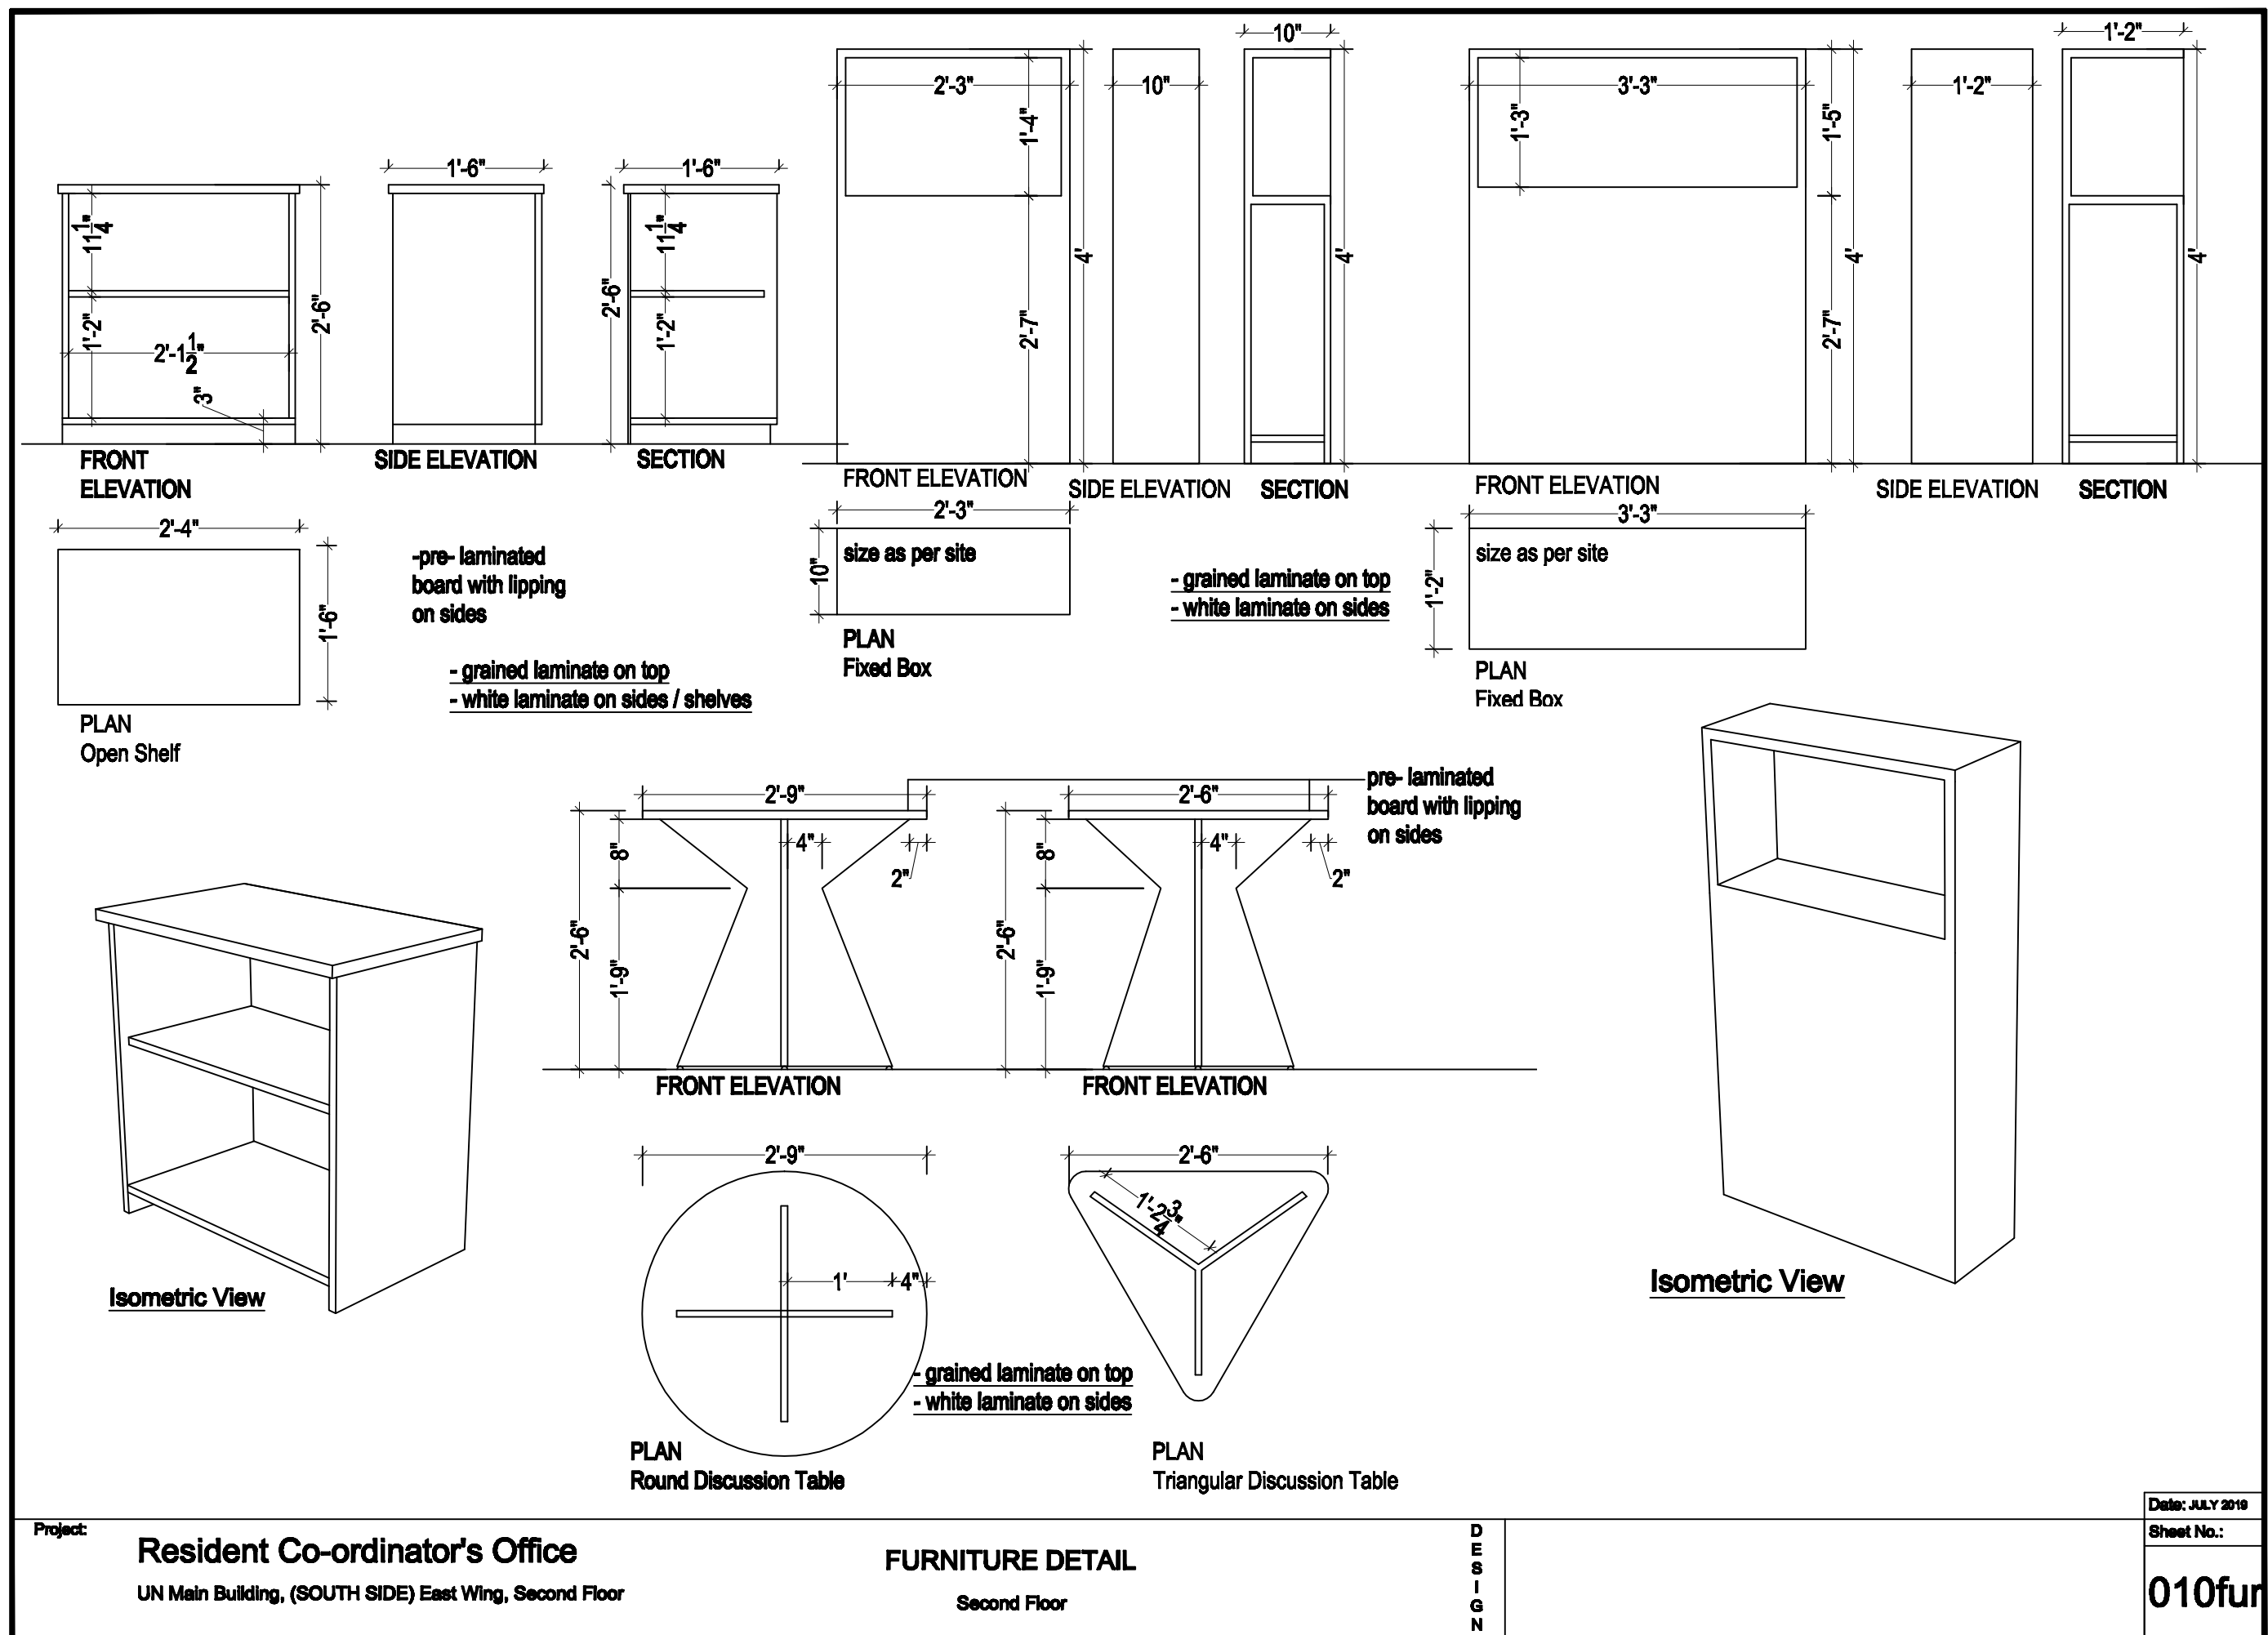

Date: JULY 2019

Sheet No.:

010fur

Project:


Resident Co-ordinator's Office

UN Main Building, (SOUTH SIDE) East Wing, Second Floor

FURNITURE DETAIL

Second Floor

D
E
S
I
G
N

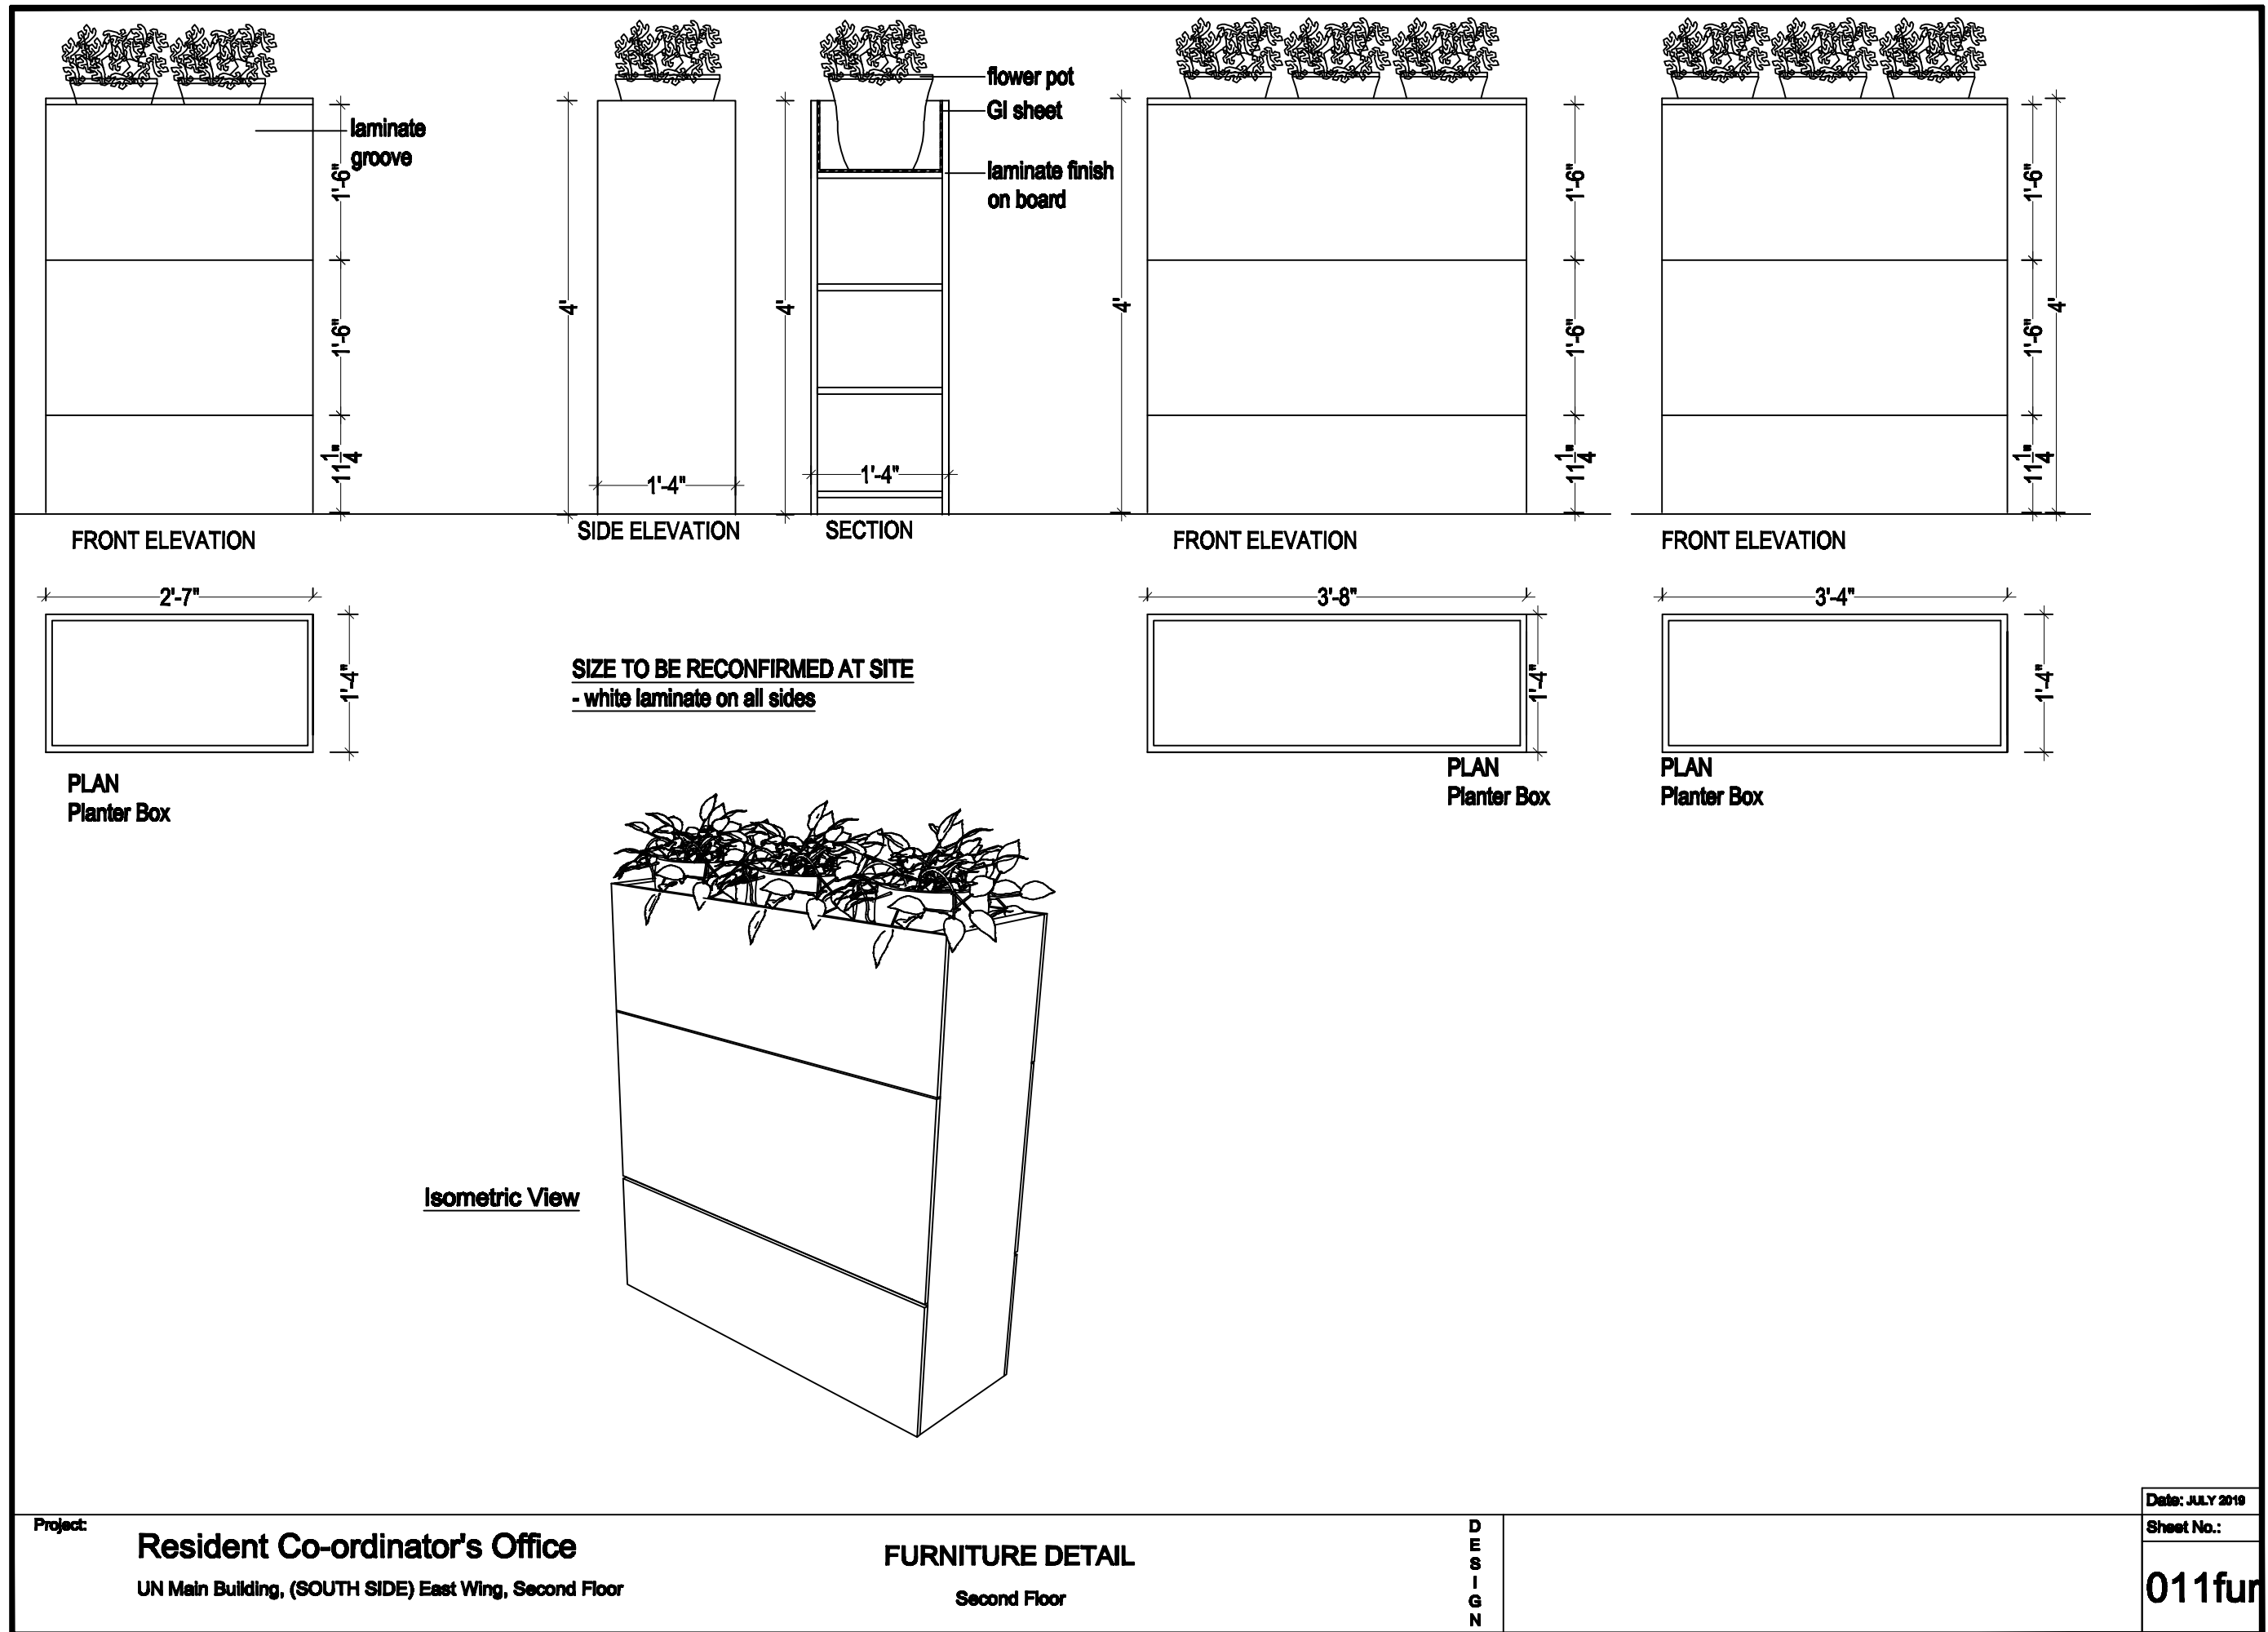

Date: JULY 2019

Sheet No.:

011fur

Project:

Resident Co-ordinator's Office
UN Main Building, (SOUTH SIDE) East Wing, Second Floor

FURNITURE DETAIL
Second Floor

D
E
S
I
G
N