

NOTES:

# ELECTRICAL DRAWINGS

**MINISTRY OF EDUCATION CENTER**

DESIGNED BY:  
March. Ibrahim Alhindi

ELECTRICAL WORKS			
APPROVED / AUTHORIZED	DESIGNED	DATE	BY
Responsible Engineer	Responsible Engineer	Responsible Engineer	Responsible Engineer
Responsible Engineer	Responsible Engineer	Responsible Engineer	Responsible Engineer



European Union  
Empowered lives.  
Resilient nations.

Ministry of Education and Higher Education  
Of The State of Palestine / وزارة التعليم العالي والبحث العلمي  
Gaza - Jenin



COVER

SCALE	1:100	DATE	E-00
For review	<input type="checkbox"/>	For approval	<input type="checkbox"/>
For tender	<input checked="" type="checkbox"/>	For construction	<input type="checkbox"/>
For construction	<input type="checkbox"/>		






 


 
 
 






 










 




 


 
 




 





 



 

 

 

 







 
 
 


 

 

 











MINISTRY OF EDUCATION CENTER  
P.O. BOX 10000, GAZA  
TEL: 03-3250000 FAX: 03-3250000

# Drawings List
   
## Electrical Legend



E-00	Electrical Legend and List Of Drawings
E-01	Ground Floor Lighting System
E-02	Ground Floor Power and LV Systems
E-03	Ground Floor Fire Alarm, Intrusion System and Speaker Systems
E-04	Ground Floor Electromechanical System
E-05	Roof Lighting and Intrusion Systems
E-06	Roof Power and LV Systems
E-07	Roof Electromechanical System
E-08	DB-1 and DB-4
E-09	DB-2 and DB-3
E-10	

SYMBOL	DESCRIPTION	SYMBOL	DESCRIPTION	SYMBOL	DESCRIPTION	
	LIGHTING FIXTURE & SWITCHES H= ( cm ) a.f.f.					
	EMERGENCY KIT INSIDE LIGHTING FIX. (OH FOR 0-36V FL LAMPS		MAIN ELECTRIC BOARD L.V. SIDE		TELEPHONE SOCKET OUTLET	x12
	Ceiling suspended lighting point / Fixture		METAL ELECTRIC BOARD WITH LDW VOLTAGE SIDE		T.V. SOCKET OUTLET	x12
	10x 5 watt Cree LED spot lighting fixtures white oven painted aluminum		DISTRIBUTION BOARD		DATA SOCKET OUTLET	x18
	2x13V PL GLOBE LIGHT (FOR STAIR & BATH)		GENERATOR		LDW VOLTAGE BOX	
	Night Light 3 Watt LED with aluminum grill R2B 64x30		THREE PHASE KWHM		COMPUTER PATCH PANEL	
	UP-DOWN SWITCH FOR SHUTTERS		SINGLE PHASE KWHM		INTERCOM	
	SHUTTER MOTOR		4-POLE CHANGE OVER SWITCH MANUAL OR AUTO		Wifi-Point	x3
	1x26 watt PL wall mount opul. IP65 fixture as thorn Eyekon		THREE/SINGLE PHASE FUSE		Data Cabinet*	
	LED TYPE WITH STAIR SIGN AND ARROWS EMERGENCY LIGHTING FIX.		THREE/SINGLE PHASE RELAY		RC 59 VIEWING RJ 45 VIEWING VGA VIEWING VIDEO	Panel
	Wall Recessed 3 Watt Led		THREE/SINGLE PHASE MCB		PROJECTOR	CEILING
	Artemis GLS 75w 230v E-27		STEP RELAY		VGA	CEILING
	Lighting Columns		INDICATOR LAMPS WITH PUSH BUTTON		CCTV SYSTEM	
	1x11V above mirror decorative with opul cover		TRANSFORMER		INDOOR CAMERA CEILING, MURAL	
	Bell		CHECK BOX		FIXED INDOOR COLORED CAMERA	
	2x13V PL GLOBE LIGHT (FOR STAIR & BATH)		60x60CM ELECTRICAL MANHOLE		DOME INDOOR COLORED CAMERA	x13
	INTERMEDIATE SWITCH		60x60CM TELEPHONE MANHOLE		FIXED OUTDOOR COLORED CAMERA DAY/NIGHT	x5
	PUSH BUTTON				SPLIT SCREEN MONITOR	
	BELL				CCTV CENTRAL MONITOR	
	SINGLE PILE ONE GANG SWITCH / W.P.				ACCESS CONTROL SYSTEM	
	SINGLE PILE TWO GANG SWITCH / W.P.				ACCESS CONTROL JUNCTION BOX	
	SINGLE PILE THREE GANG SWITCH / W.P.				ACCESS CONTROL PANEL	180
	SINGLE PILE FOUR GANG SWITCH / W.P.				CARD READER	150
	TWO WAY SWITCH / W.P.				ELECTRICAL LOCK	
	MAGNETIC LOCK				OPEN PUSH BUTTON	Door
	OPEN PUSH BUTTON				SUPERVISORY MAGNET	
	SINGLE PHASE (2POLE) ISOLATOR, Rate As indicated				INTRUSION SYSTEM	
	THREE PHASE (4POLE) ISOLATOR, Rate As indicated				DUAL TECH IR/MICROWAVE MOTION DETECTOR	220
	16A 3 PIN TRIPLE SOCKET OUTLET				VIBRATION DETECTOR	200
	16A 3 PIN TWIN SOCKET OUTLET / W.P.				LED PANIC BUTTON	Floor
	16A 3 PIN SOCKET OUTLET / W.P.				KEYPAD	150
	16A 3 PIN SOCKET OUTLET / W.P.				BURGLAR ALARM CONTROL PANEL	180
	16A 3 PIN SOCKET OUTLET / W.P.					
	16A 3 PIN SOCKET OUTLET / W.P.					
	16A 3 PIN SOCKET OUTLET / W.P.					
	16A 3 PIN SOCKET OUTLET / W.P.					
	16A 3 PIN SOCKET OUTLET / W.P.					
	16A 3 PIN SOCKET OUTLET / W.P.					
	16A 3 PIN SOCKET OUTLET / W.P.					
	Double UPS socket					

## NOTES:



## NOTES:

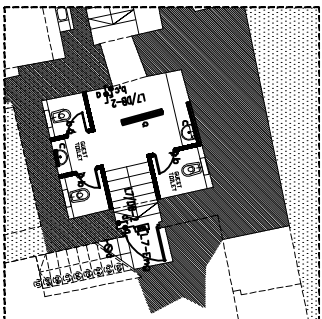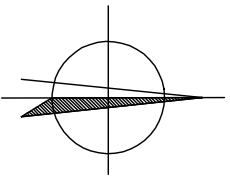

**JERUSALEM DESIGN CENTER**

March. Ibrahim Alhindi

## ELECTRICAL WORKS


KIMCHI-DAT ALBAYANIR Electrical Engineer Consulting Office 108-10000 Highway 97 North Van Nuys, California 91411	Duty Title	Eng. Visit Record
	Credited & Approved	Eng. Initials / Date



**OLD CITY - JERUSALEM**



Ground Floor  
Lighting System

DATE	11-00	SHEET NO.	E-01
<input type="checkbox"/> For review		EDITION	
<input type="checkbox"/> For approval			
<input checked="" type="checkbox"/> For tender			
<input type="checkbox"/> For construction			
04/12/2005			



**JERUSALEM DESIGN CENTER**  
Architects, Engineers & Consultants

**TEL**

Box 19276, Jerusalem Tel. 02-2345698 Fax. 02-2345719



## NOTES:

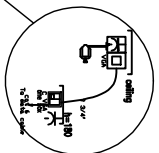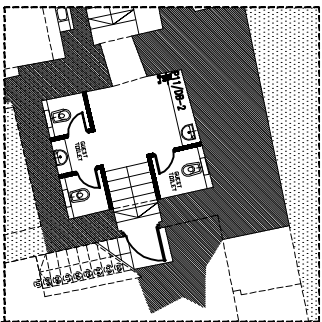

**JERUSALEM DESIGN CENTER**

March. Ibrahim Alhindi

## ELECTRICAL WORKS


<b>MIDWAY ALUMINUM</b> <b>Electrical Engineer</b> <b>Consulting Office</b> 17500 Midway Road, Dallas 75244-2028	<b>Design Team:</b>	<b>Eng. Staff Required</b>
	<b>Contract &amp; Approval</b>	<b>Eng. Related Material</b>



**Rehabilitation Of The Madras Assembly &  
Of The Hassan Assembly & Hassan Assembly  
OLD CITY - JERUSALEM**



## Ground Floor Power and LV Systems



DATE	1:00	SHEET NO.	E-02
<input type="checkbox"/> For review <input type="checkbox"/> For approval <input checked="" type="checkbox"/> For tender <input type="checkbox"/> For construction	EXTERN 		
04/12/2005			

**IRB**  
**ISRAELI DESIGN CENTER**  
*Architects, Engineers & Consultants*

**O.Box 19276, Jerusalem Tel. 02-2343696 Fax. 02-2343719**



NOTES:

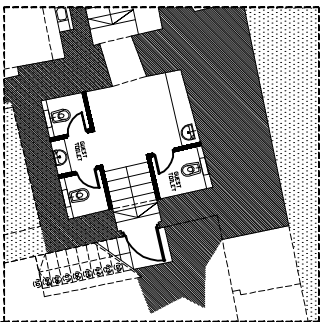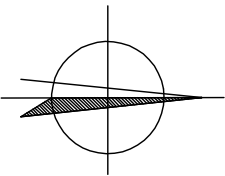

**JDC**  
**JERUSALEM DESIGN CENTER**

DESIGNED BY:  
March, Ibrahim Alhindi

**ELECTRICAL WORKS**

DESIGNED BY: **March, Ibrahim Alhindi**  
CHECKED BY: **Eg. M. Alhindi**  
DATE: **12/12/2023**



PROJECT:  
**Substitution Of The Existing Alhindi & Alhindi**  
**Of The Jerusalem Design Center**  
LOCATION: **JERUSALEM**




Sheet Name: **Ground Floor**  
Title: **Fire Alarm, Intrusion System and Speaker Systems**

SCALE: **1:100**  
SHEET NO.: **E-03**  
EDITION: **1**

**JDC**  
**JERUSALEM DESIGN CENTER**  
P.O. BOX 12376, JERUSALEM TEL: 02-2345678 FAX: 02-2345679



## NOTES:

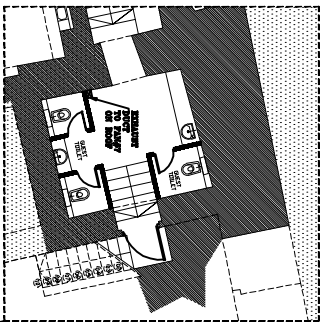

**JDC**  
**JERUSALEM DESIGN CENTER**

March. Ibrahim Alhind

## ELECTRICAL WORKS


<b>MINI-DAT ALABAMA</b> <b>Electrical Engineer</b> <b>Consulting Office</b> 10000 Highway 206, NW Huntsville, AL 35894-0001	<b>Design Team</b> Eng. Mike Powell
	<b>Contract &amp; Approval</b> Eng. Michael Hefner



**Modernization Of The Modern Arabians &  
Of The Modern Arabians & Modern Arabians**  
**OLD CITY - JERUSALEM**




Ground Floor  
Electromechanical System

DATE	11-00	SHEET NO.	E-04
<input type="checkbox"/> For review	<input type="checkbox"/> For approval	EDITION:	
<input type="checkbox"/> For tender	<input type="checkbox"/> For construction		
04/11/2008			

**interline**  
**INTERLINE DESIGN CENTER**  
*Architects, Engineers & Consultants*  
P.O. Box 19276, Jerusalem Tel. 02-2343696 Fax. 02-2343711



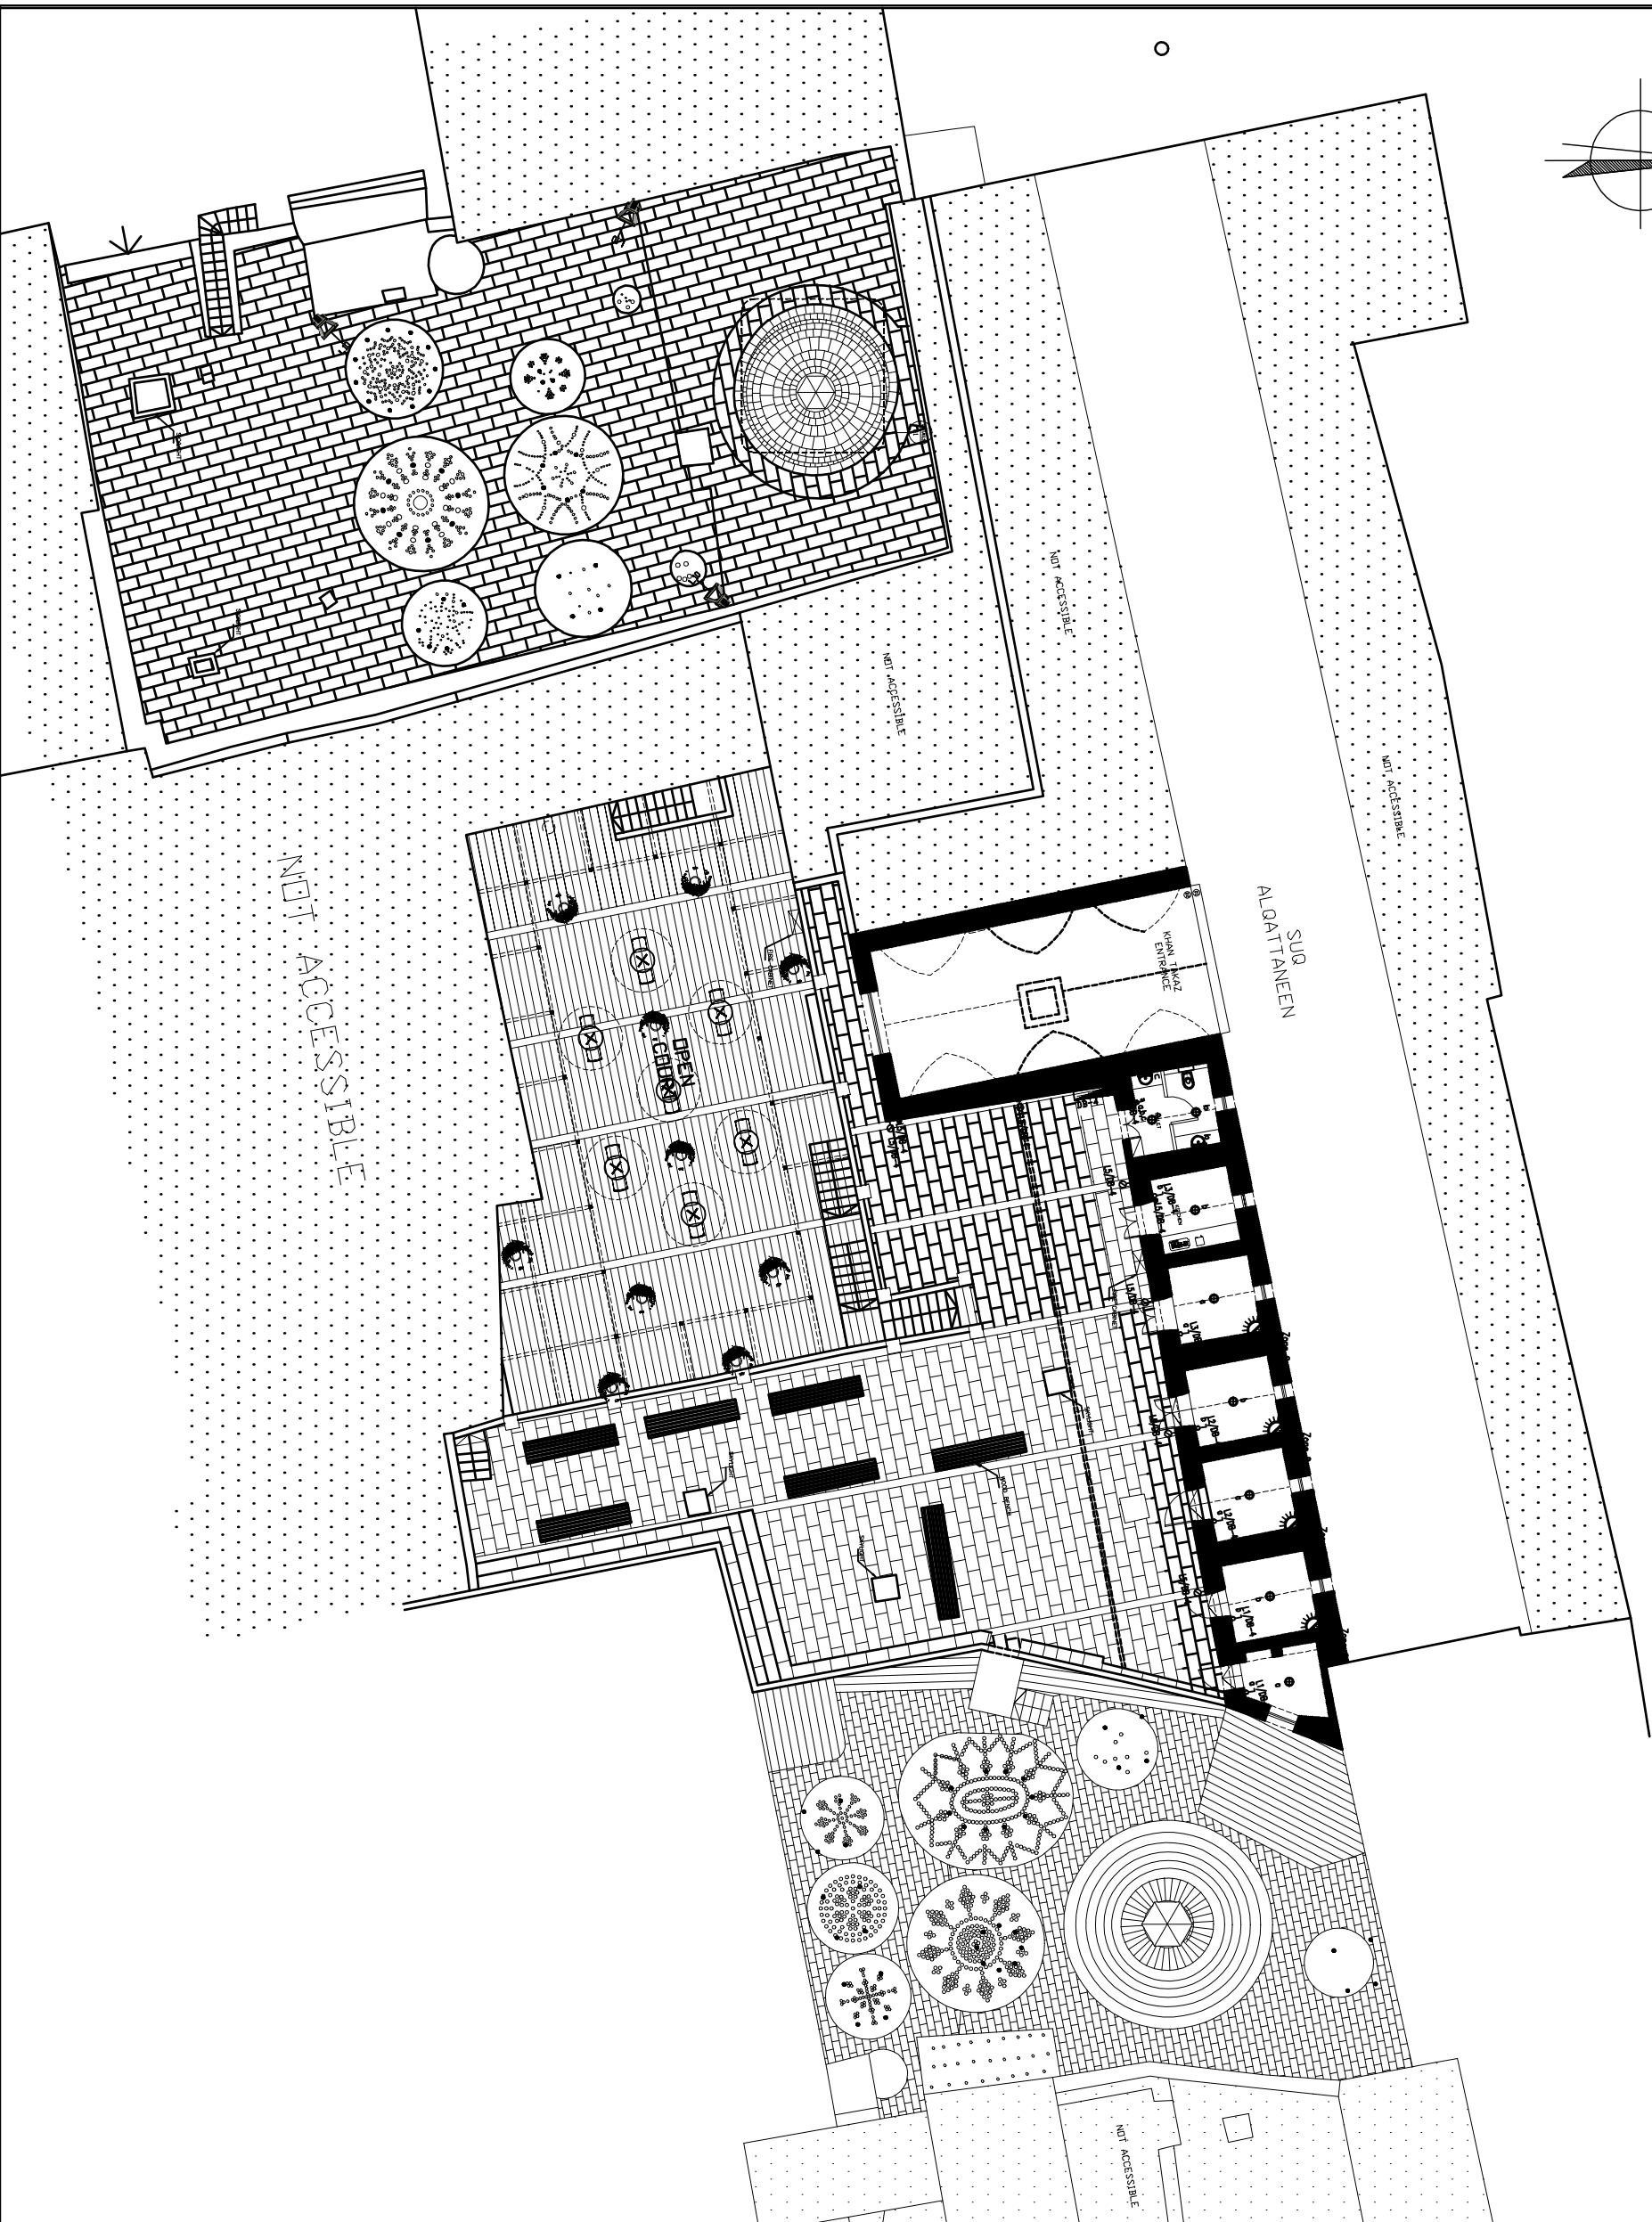

March. Ibrahim Alhindi

<b>MIDWAY ALABAMA</b> <b>Electrical Engineer</b> <b>Consulting Office</b> <b>1005 10th Avenue, Suite 100</b> <b>Tulsa, OK 74103</b>	<b>Design Team</b>	<b>Eng. With Permit</b>
	<b>Contract &amp; Approval</b> <b>Eng. Initial/Approval</b>	

<b>Design Team:</b>	<b>Eng. Nisha Patel</b>
<b>Checked &amp; Approved:</b>	<b>Eng. Mahesh Acharya</b>



**PROJECT:**  
**Rededication Of The Madras Al-Tawqiyah &**  
**Of The Himmam Al-qura & Himmam Al-sha**  
**OLD CITY - JERUSALEM**




## Roof Lighting and Intrusion Syst

1  
2  
3  
4

☐ For approval



☐ For construction

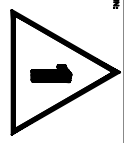

**INTERALUM DESIGN CENTER**  
*Architects, Engineers & Consultants*

**ifc**

P.O. Box 19276, Jerusalem Tel. 02-2345686 Fax. 02-2343715

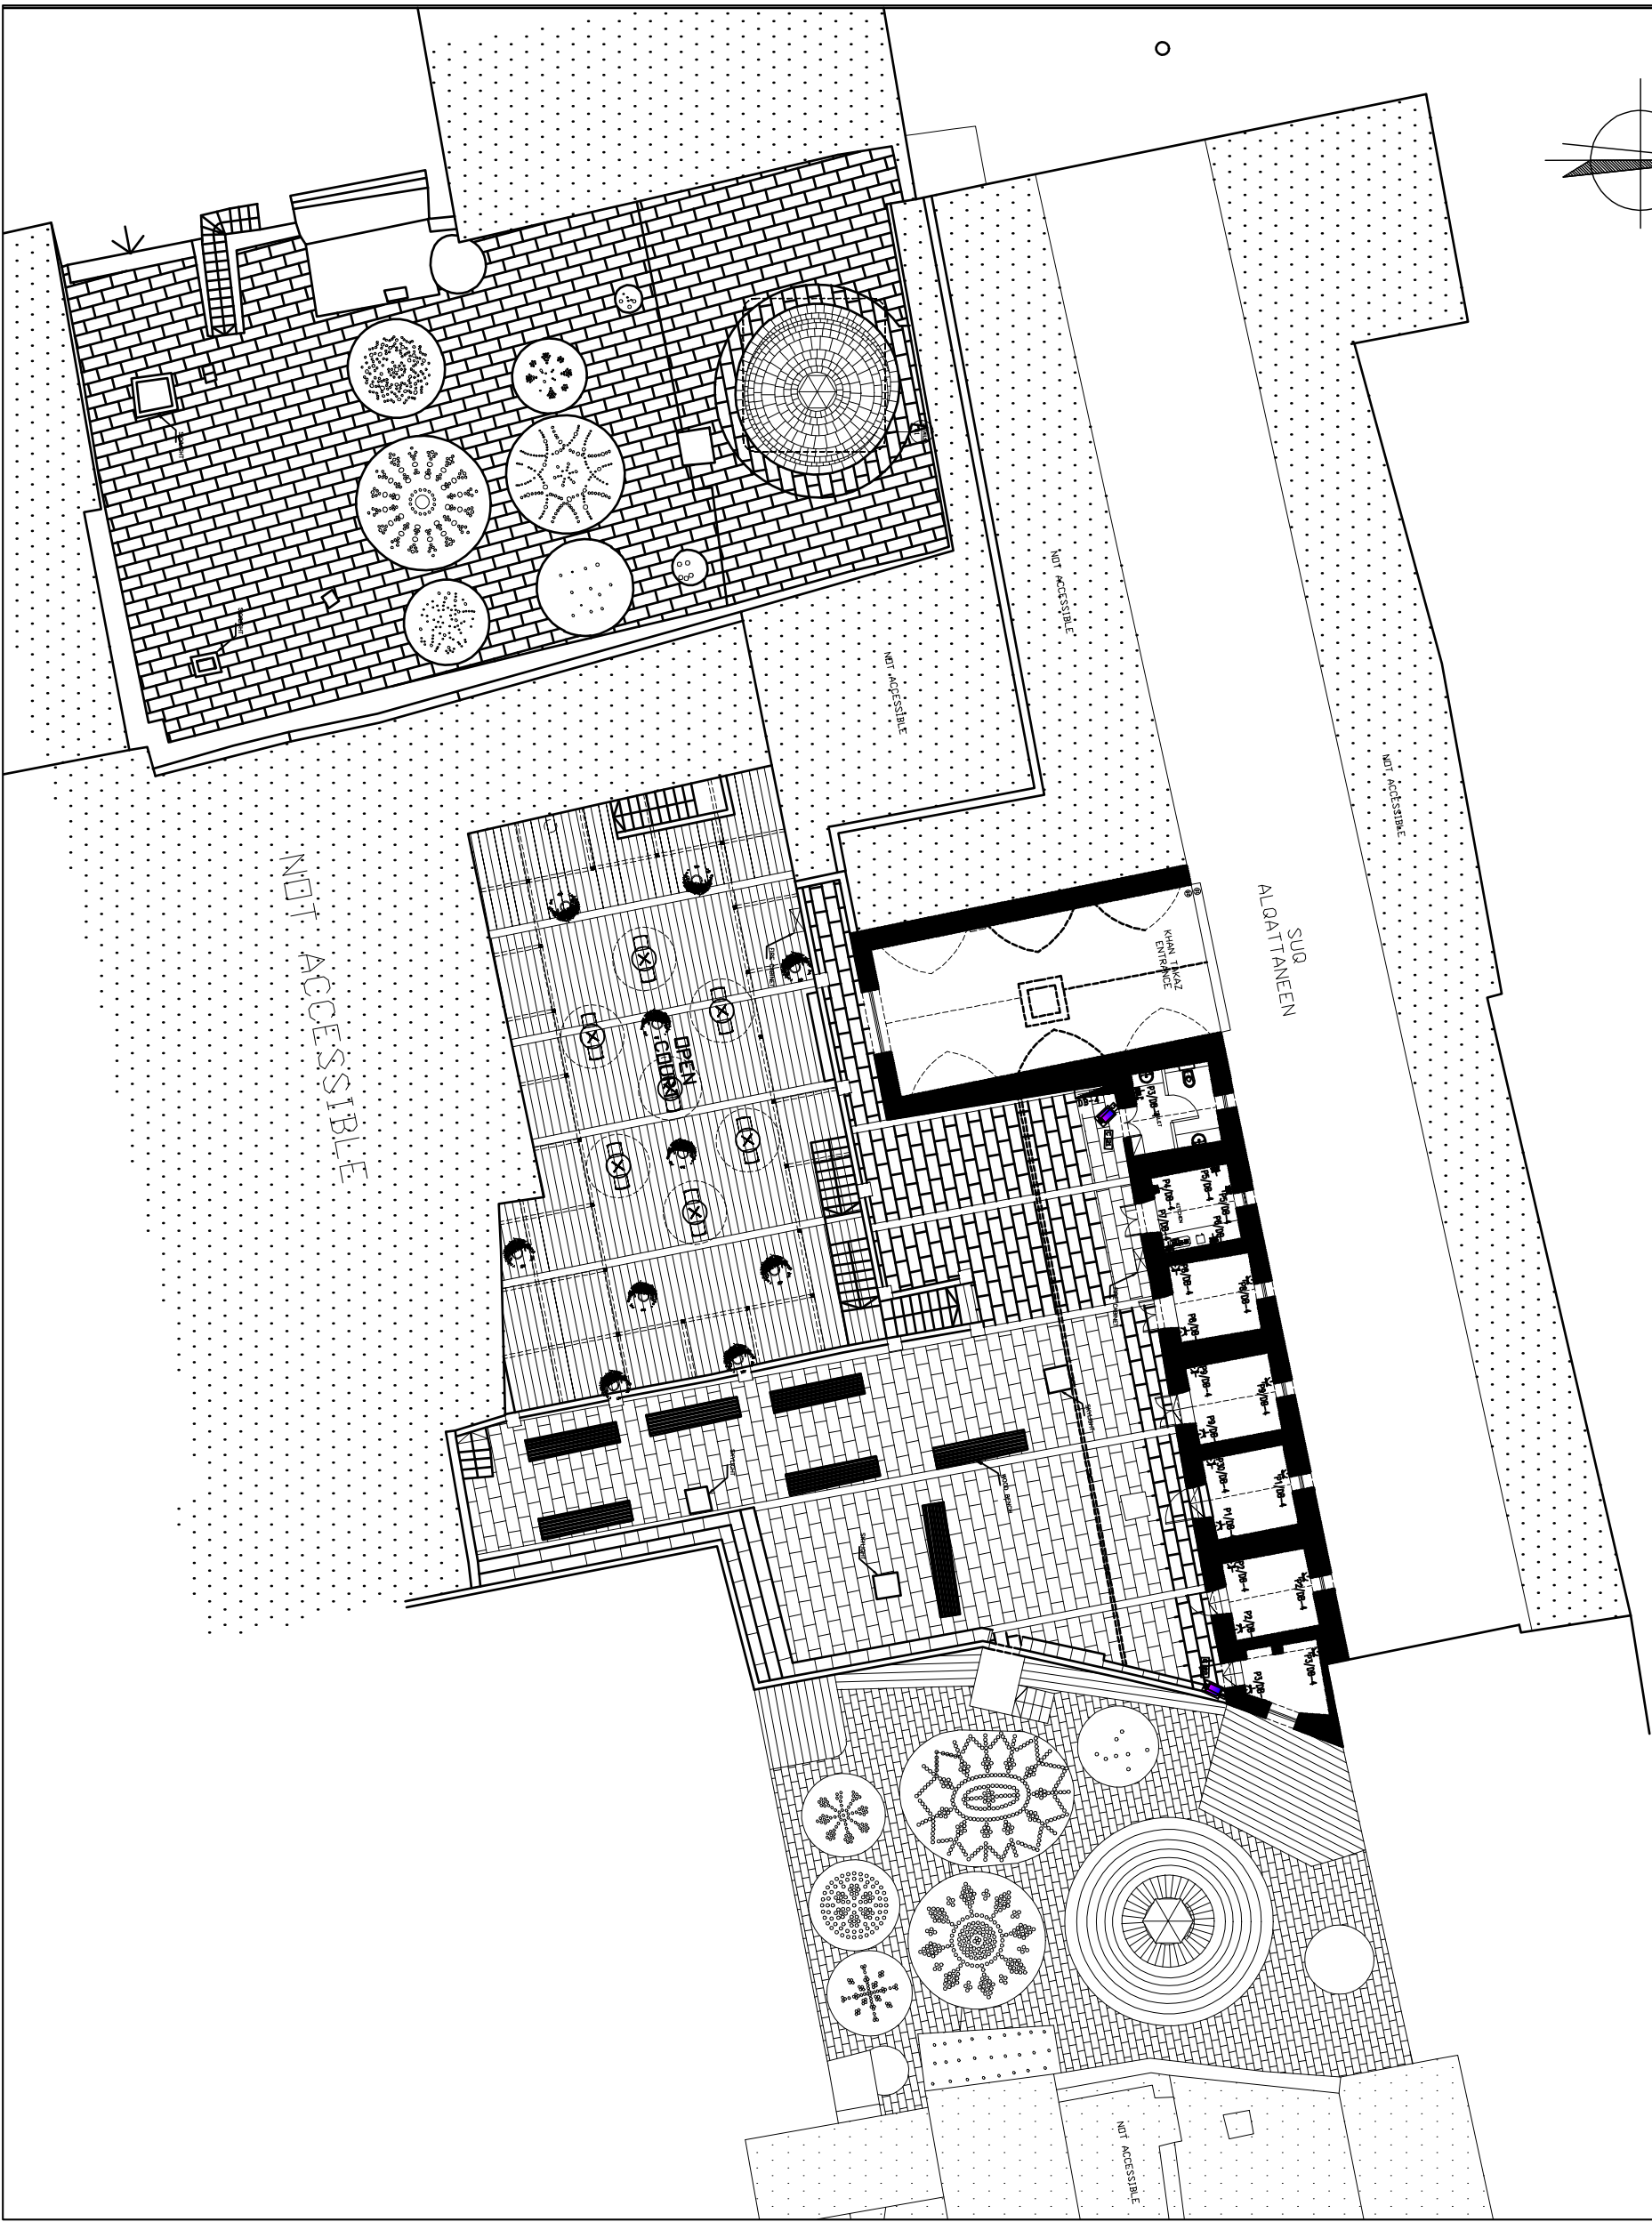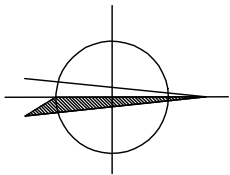

NOTES:

**JDC**  
**JERUSALEM DESIGN CENTER**

DESIGNED BY:  
March, Ibrahim Alhindi

**ELECTRICAL WORKS**

ARCHITECT: ALABRAHIM Electrical Engineer Consulting Offices Jerusalem, Palestine	Design Team: Egi, Mubhammad Checked & Approved: Egi, Mubhammad
---	---



PROJECT:  
**Substitution Of The Lowvoltage Transformers &  
Of The Highvoltage Air-ops & Highvoltage Air-ops  
OLD CITY - JERUSALEM**



Sheet Name:  
**Roof  
Power and LV Systems**


SCALE: 1:100 SHEET NO.: E-06

<input type="checkbox"/> For review <input type="checkbox"/> For approval <input checked="" type="checkbox"/> For tender <input type="checkbox"/> For construction	EDITION: <b>1</b>
---	----------------------

**JDC**  
**JERUSALEM DESIGN CENTER**  
Jerusalem, Palestine  
P.O.Box 18276, Jerusalem TEL: 02-2345895 FAX: 02-2345778



**NOTES:**

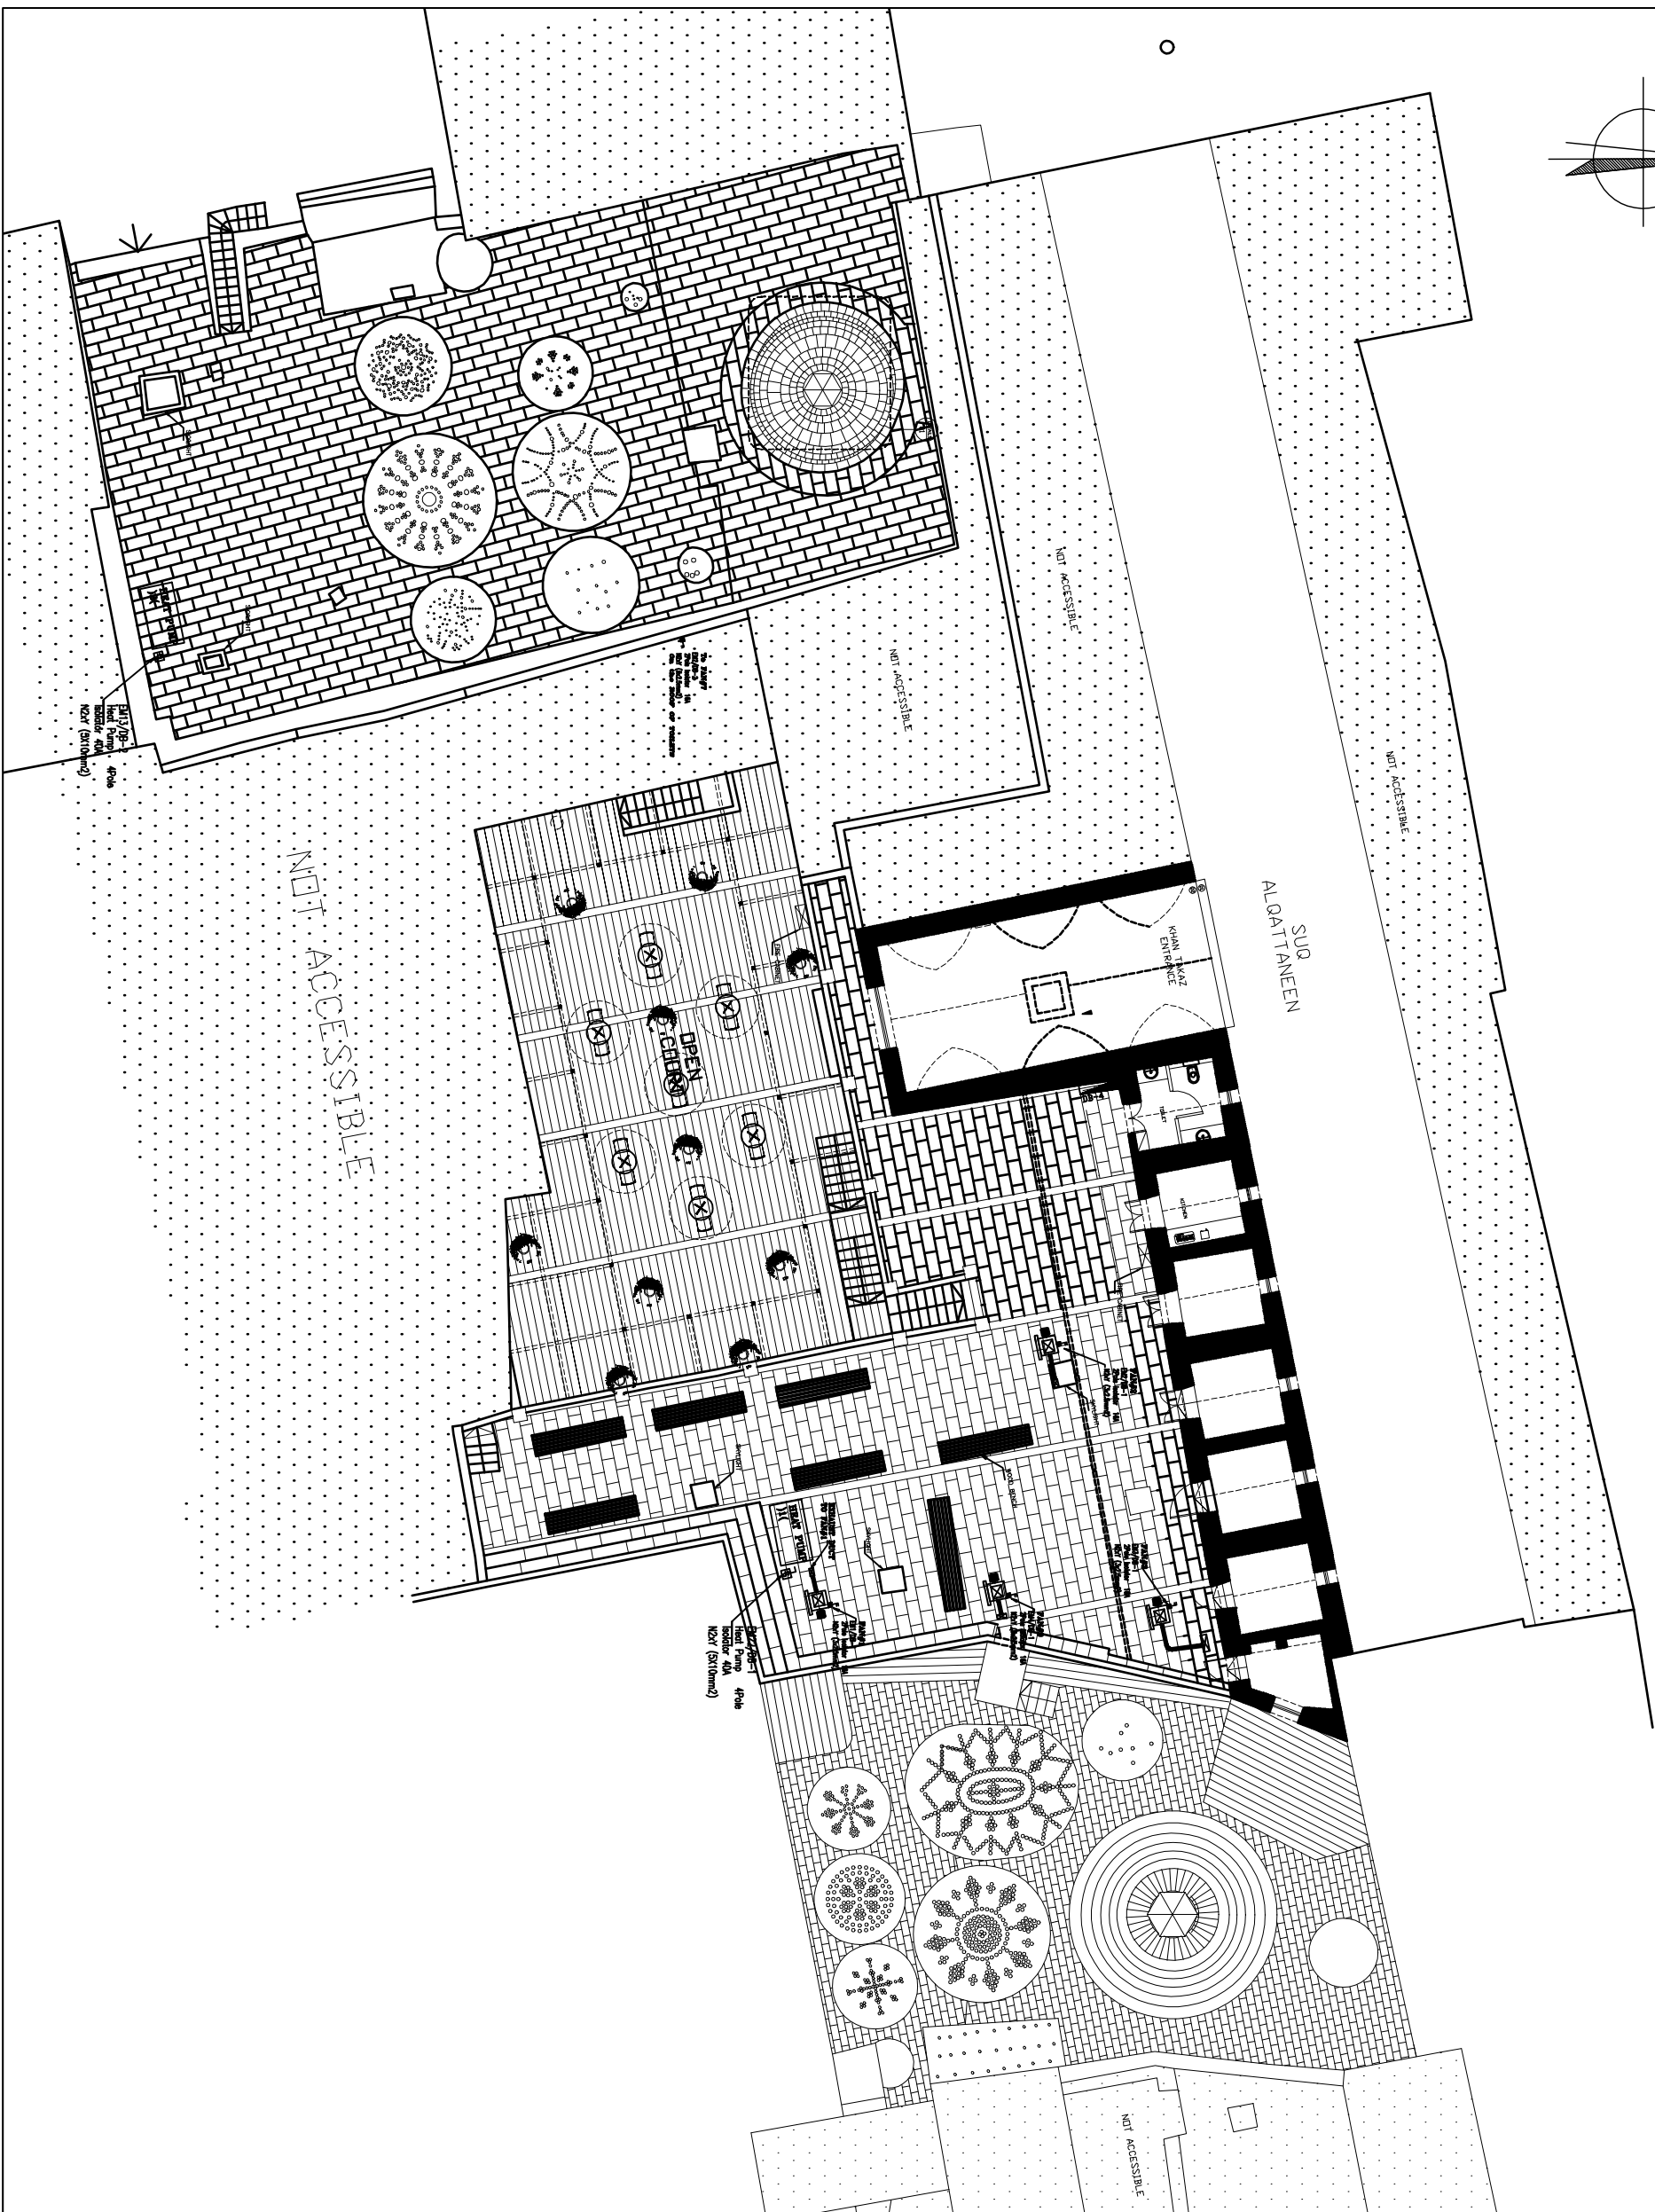

**JERUSALEM DESIGN CENTER**

DESIGNED BY  
March. Ibrahim Alhindi

ELECTRICAL WORKS	
ITEM NO.	DESCRIPTION
1	...
2	...
3	...
100	...

<b>MIDHAT ALSHAIKH</b> <b>Electrical Engineer</b> <b>Consulting Office</b> 10000 Midway Road Houston, TX 77055 Tel: 281/462-0233	<b>Design Team:</b>	<b>Eng. Staff:</b>
	<b>Checked &amp; Approved:</b>	<b>Eng. Initials:</b>




**PROJECT:**  
**Redevelopment Of The Meadows At Montgomery & Park**  
**Of The Hammond At-again & Hammond At-again**  
**OLD CITY - JERUSALEM**



# Roof Electromechanical System

SCALE	1:100	SHEET NO.	F-07
-------	-------	-----------	------

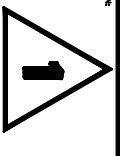


**NEUSALIM DESIGN CENTER**

**P.O.Box 19276, Jerusalem Tel. 02-2343696 Fax. 02-2343719**


DB1

$$DB-1$$


FEEDER SOURCE	ELECTRICAL COMPANY	
MAIN FEEDER		

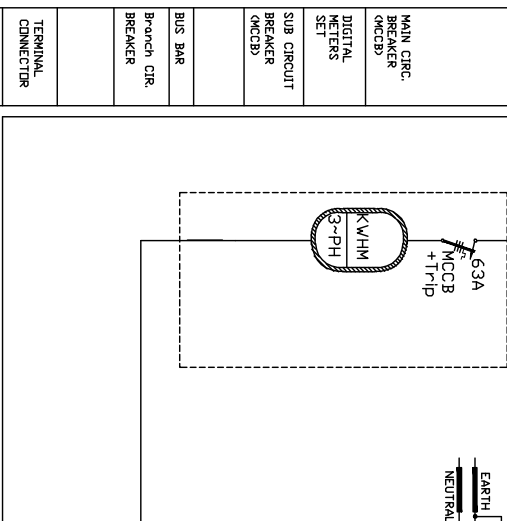CIRCUIT NO. \_\_\_\_\_CIRCUIT


DESCRIPTIONS	
■	ALL MOCB'S (40A-250A) ARE MOELLER - 35KA.
■	ALL MOCB'S ARE MOELLER - 10KA (TYPE FASZ).
■	METAL SHEET FOR MOB IS 2 MM.
■	PAINTING WITH POWDER COATING RAL 7002 POBBLE GREY.

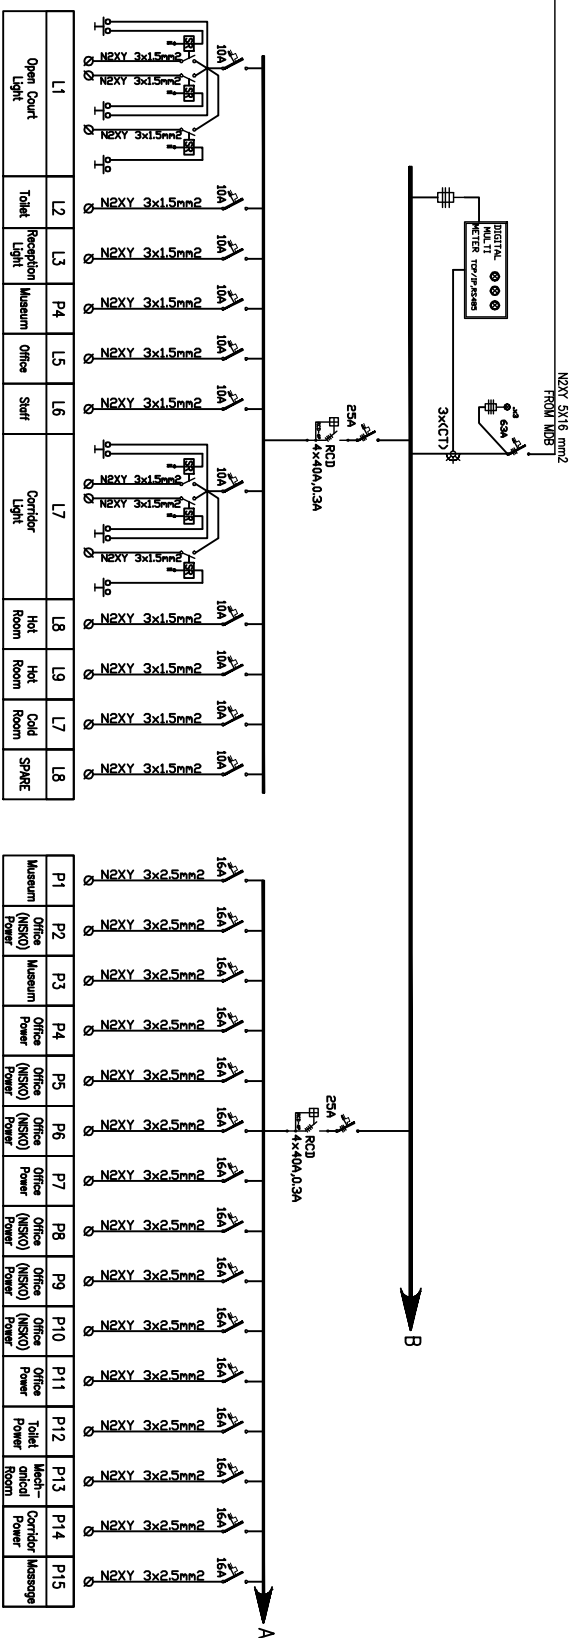

P1	P2	P3	P4	P5	P6	P7	P8	P9	P10	P11	P12	P13	P14	P15
Museum	Office Power	Museum	Office Power	Office (NISO)	Office Power	Office Power	Office (NISO)	Office (NISO)	Office (NISO)	Office Power	Telnet Room	Mail-Corridor official	Message-Power	

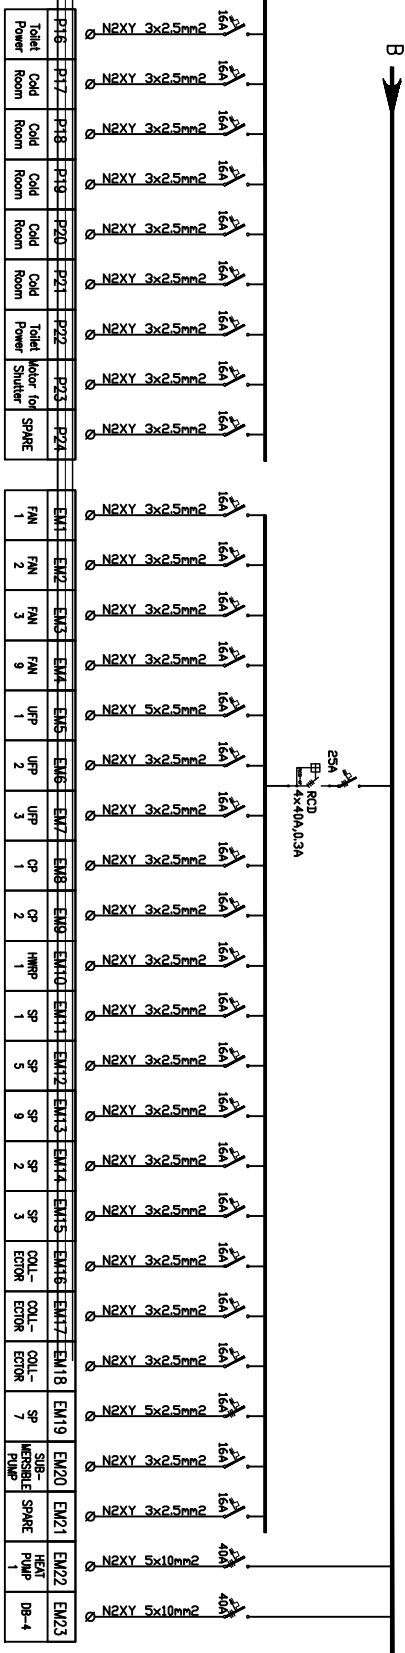

P16	P17	P18	P19	P20	P21	P22	P23	P24	DM	DM2	DM3	DM4	DM1000
Table Room	Table Room	Table Room	Table Room	Table Room	Table Room	Table Room	Table Room	Table Room	FN	FN	
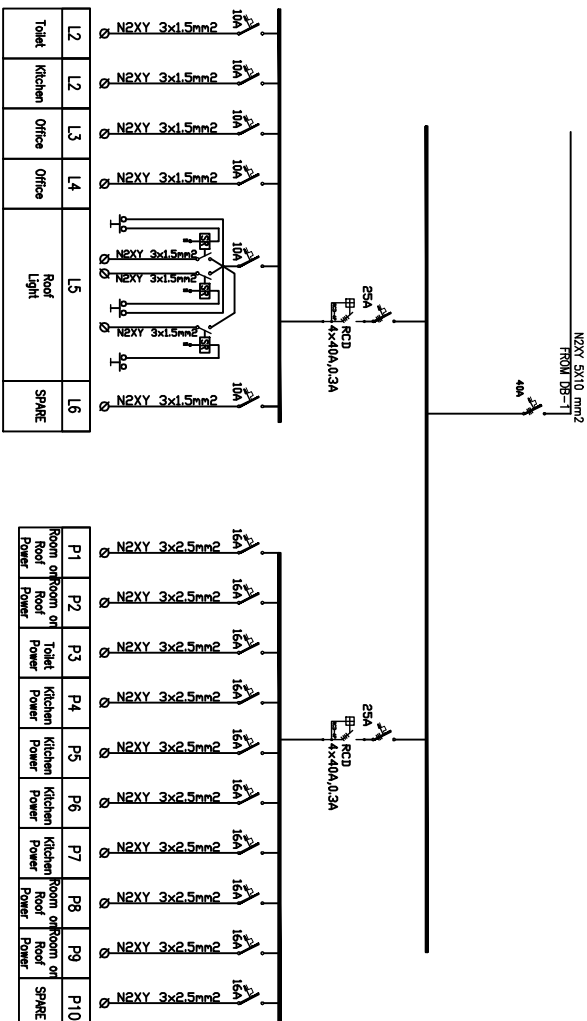

L2	L2	L3	L4	L5	L6	
Toilet	Kitchen	Office	Office	Roof Light	SPARE	

P1	P2	P3	P4	P5	P6	P7	P8	P9	P10
Room onRoom or Roof Roof Power Power	Toilet Power	Kitchen Power	Kitchen Power	Kitchen Power	Kitchen Power	Room onRoom or Roof Roof Power Power	Room onRoom or Roof Roof Power Power	Room onRoom or Roof Roof Power Power	SPARE

**NOTES:**



MArch. Ibrahim Alhindi

## ELECTRICAL WORKS


<b>MIDHAT AL-HANIFI</b> <b>Electrical Engineer</b> <b>Consulting Office</b> No. 40296 Jeddah, Saudi Arabia Tel: 870-0101	<b>Design Team:</b>  <b>Erg. Matar /Matar</b>
	<b>Checked &amp; Approved:</b>  <b>Erg. Matar /Matar</b>



**PROJECT**  
**Rededication Of The Madonna Altarpiece &**  
**Of The Humanness Al-qua & Humanness Al-dide**  
**OLD CITY - JERUSALEM**



DB-1 and DB-4


DATE 11-00	PROJECT NO. E-08
<input type="checkbox"/> For review <input type="checkbox"/> For approval <input checked="" type="checkbox"/> For tender <input type="checkbox"/> For construction	EXCHG: 
047622008	







NOTES:

BOARD NAME : DB-2	
FEEDER SOURCE	ELECTRICAL COMPANY
MAIN FEEDER	
MAIN CIRC. BREAKER (MCBB)	63A MCCB + Trip
DIGITAL METERS SET	
SUB CIRCUIT BREAKER (MCBB)	
BUS BAR	
Branch CIR. BREAKER	
TERMINAL CONNECTOR	
CIRCUIT NO.	
CIRCUIT TARGET	
DESCRIPTIONS	** ALL MCCBS (40A-250A) ARE MOELLER - 3SKA.
	** ALL MCBS ARE MOELLER - 10KA (TYPE FA2S).
	** METAL SHEET FOR MDB IS 2 MM
	** PAINTING WITH POWDER COATING RAL 7022 POWDER GREY.

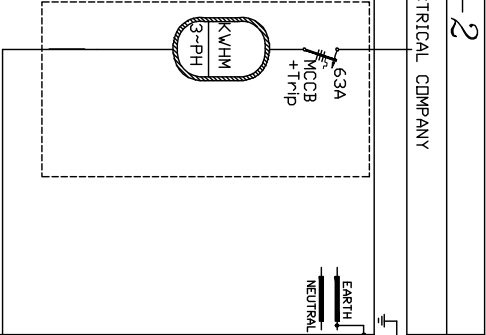

DB2

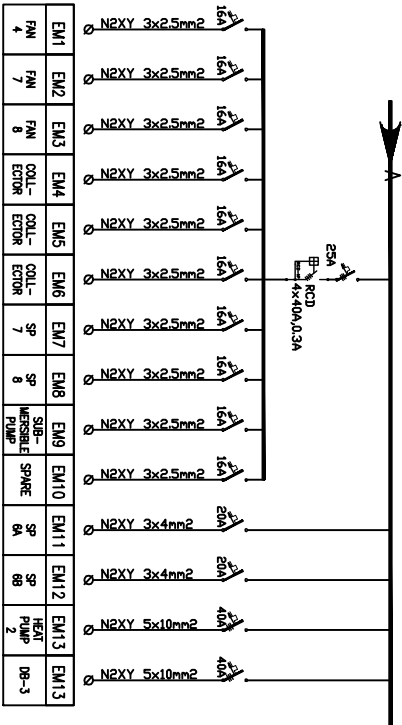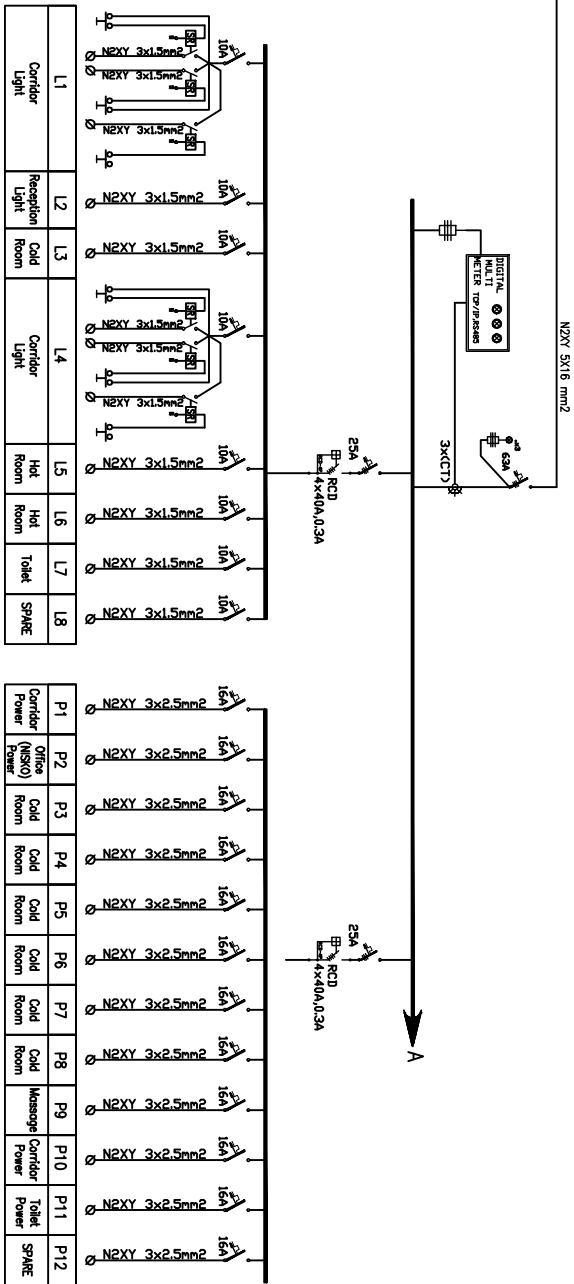

DB3

