

Key Plan

LEGEND

ALUMINUM POLE, 2.5 M HIGH EQUIPPED WITH 2 LIGHTING FIXTURES, 2X25W ECD DL LAMP, IP 65

SUSPENDED LIGHTING FIXTURE EQUIPPED WITH 1X25W ECD DL LAMP, IP 65

FLOODLIGHT ON 1M ALUMINUM STAND EQUIPPED WITH 50W LED LAMP, IP 66

SPIKE WITH LIGHTING FIXTURE EQUIPPED WITH 12W LED LAMP, IP 66

CEILING MOUNTED FIXTURE EQUIPPED WITH 20 W ECD DL LAMP, IP 66

POWER/CONTROL PANEL, IP 65

ONE WAY ONE GANG SWITCH MOUNTED AT H=1.2M ABOVE FFL

16A DOUBLE POWER SOCKET OUTLET MOUNTED AT H=0.3M ABOVE FFL

Ø 25 EMT CONDUIT IN GARDEN FLOOR

Ø 25 PVC CONDUIT IN CEILING

REV	BY	APP	DESCRIPTION	DATE

Revisions

THIS DRAWING IS A COPYRIGHT. DO NOT SCALE FROM THE DRAWING. THE CONTRACTOR AND HIS SUB-CONTRACTORS ARE TO VERIFY ALL DIMENSIONS ON SITE BEFORE MAKING SHOP DRAWINGS OR COMMENCING MANUFACTURE.

United Nation Development Programme  
UNDP Lebanon  
Social and Local Development Programme  
P.O.Box: 11-3216 Beirut, Lebanon Tel: 961 1 962491

PROGRAMME:

Lebanese Host Communities  
Support Programme  
Support to Integrated Service  
Provision at the Local Level

PROJECT:

REHABILITATION OF A PUBLIC  
PARK - BOURJ HAMMOUD

Sheet Information	
PROJECT NBR.	-
PROJECT PHASE	TENDER
DISCIPLINE	ELECTRICAL
SECTOR	-
BUILDING	-
DESIGNED	-
DRAWN	-
CHECKED	-
APPROVED	-
DATE	24 NOV. 2015
SCALE	-
SHEET SIZE	-



Sheet Title

ELECTRICAL LAYOUT

Sheet No.



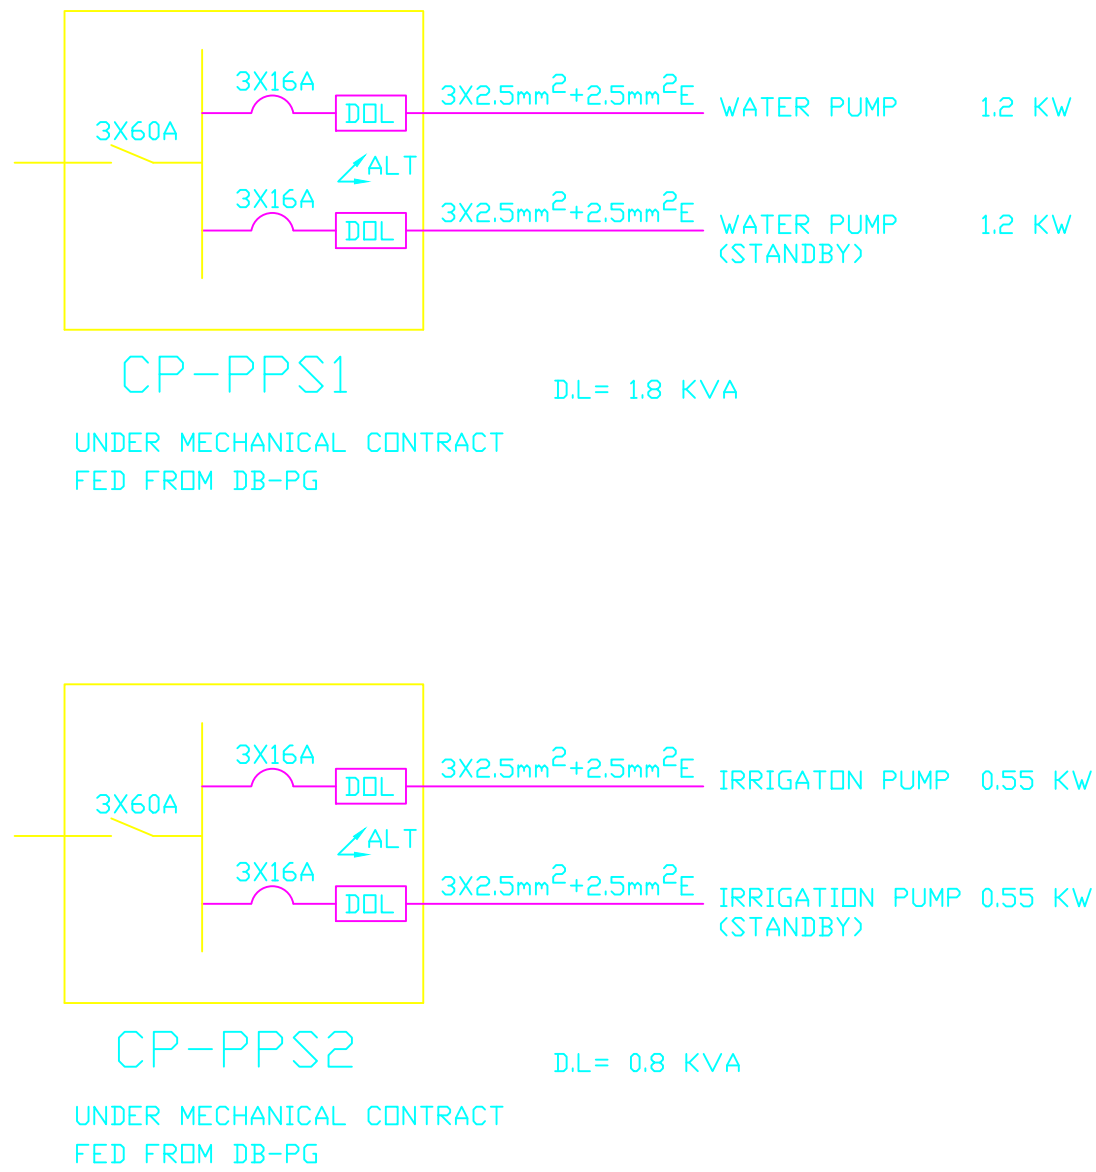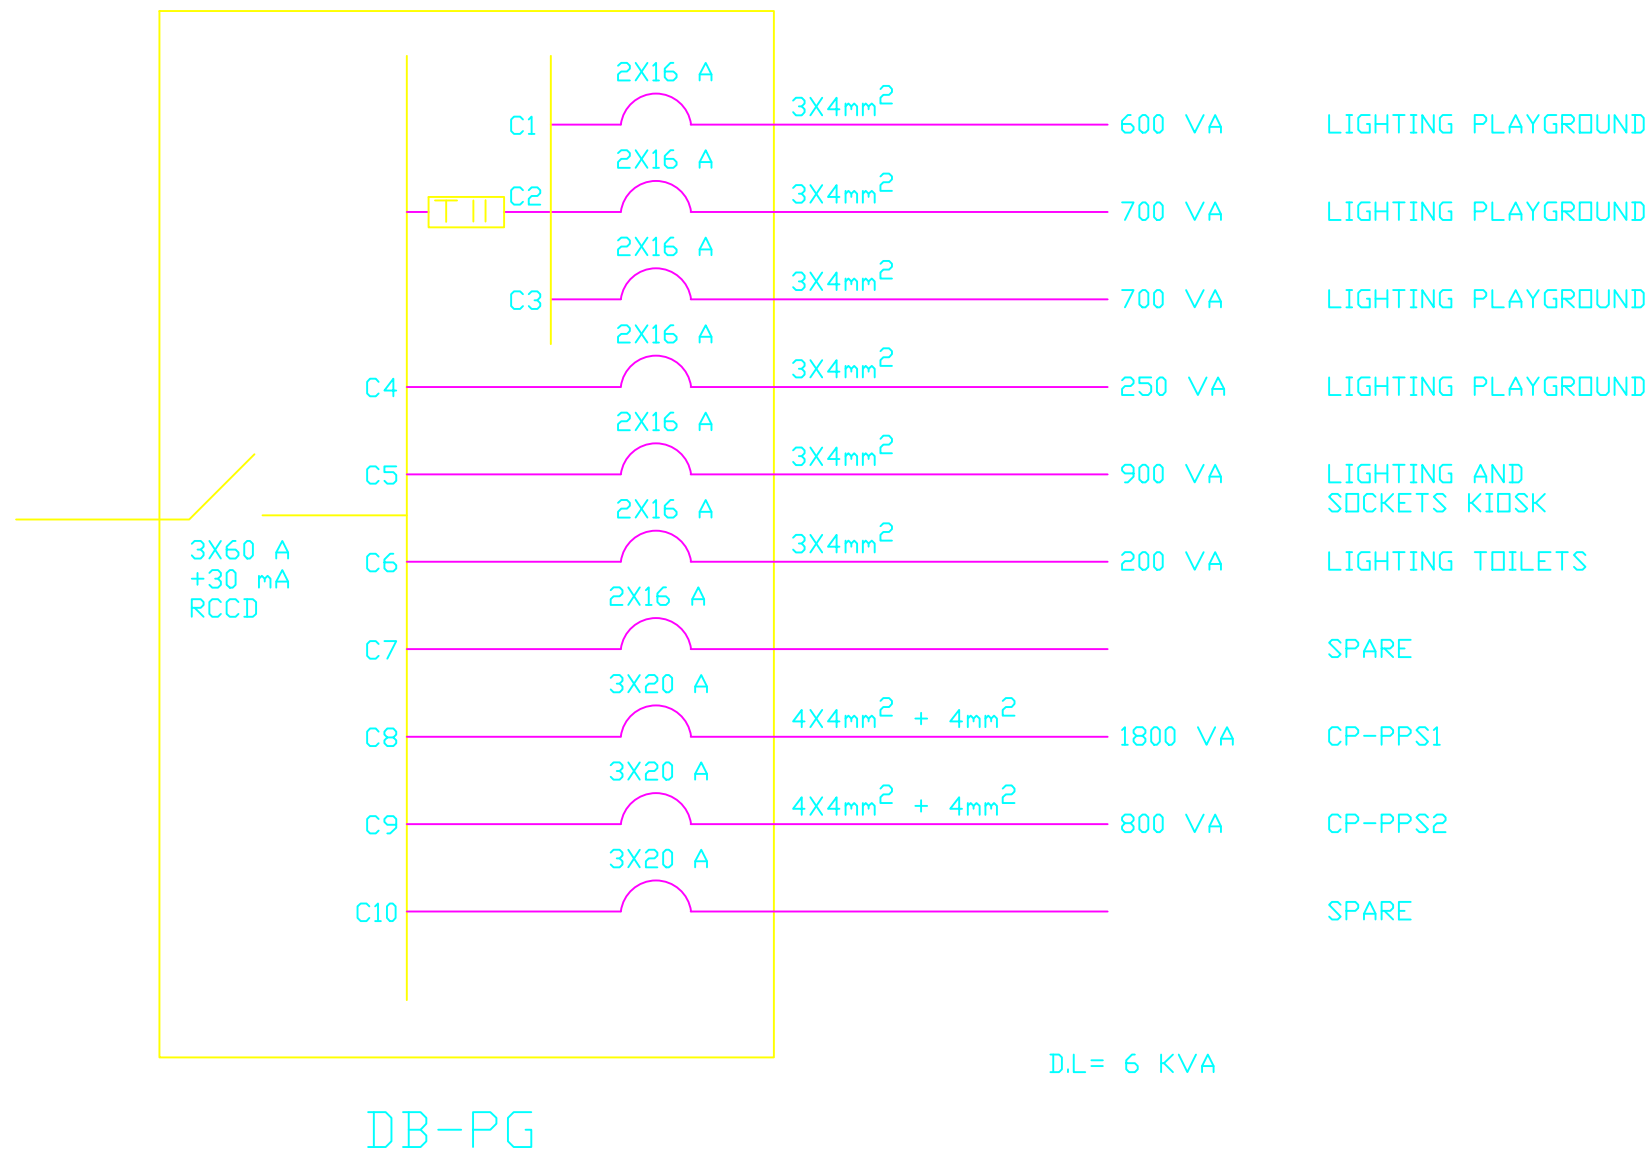

EL 01

Phase	Discipline	Floor Area	Drawing Number	Revision
-------	------------	------------	----------------	----------



## Key Plan

### LEGEND

	BREAKER
	ISOLATOR SWITCH
	DIRECT ON LINE STARTER
	TIMER + 3X20A CONTACTOR TO CONTROL PLAYGROUND LIGHTING

REV	BY	APP	DESCRIPTION	DATE

### Revisions

THIS DRAWING IS A COPYRIGHT. DO NOT SCALE FROM THE DRAWING.  
THE CONTRACTOR AND HIS SUB-CONTRACTORS ARE TO VERIFY ALL  
DIMENSIONS ON SITE BEFORE MAKING SHOP DRAWINGS OR  
COMMENCING MANUFACTURE.

United Nation Development Programme  
UNDP Lebanon  
Social and Local Development Programme  
P.O.Box: 11-3216 Beirut, Lebanon Tel: 961 1 962491

PROGRAMME: Lebanese Host Communities  
Support Programme  
Support to Integrated Service  
Provision at the Local Level

PROJECT:  
**REHABILITATION OF A PUBLIC  
PARK - BOURJ HAMMOUD**

### Sheet Information

PROJECT NBR.	-
PROJECT PHASE	TENDER
DISCIPLINE	ELECTRICAL
SECTOR	-
BUILDING	-
DESIGNED	-
DRAWN	
CHECKED	
APPROVED	
DATE	24 NOV. 2015
SCALE	-
SHEET SIZE	

### Sheet Title

PANEL DETAILS

### Sheet No.

EL 02

Phase	Discipline	Floor Area	Drawing Number	Revision
-------	------------	------------	----------------	----------