

|     |                                  |
|-----|----------------------------------|
| E0  | Title                            |
| E1  | Legend                           |
| E2  | Ground Floor Lighting System     |
| E3  | First Floor Lighting System      |
| E4  | Second Floor Lighting System     |
| E5  | Third Floor Lighting System      |
| E6  | Fourth Floor Lighting System     |
| E7  | Ground Floor Power System        |
| E8  | First Floor Power System         |
| E9  | Second Floor Power System        |
| E10 | Third Floor Power System         |
| E11 | Fourth Floor Power System        |
| E12 | Ground Floor UPS System          |
| E13 | First Floor UPS System           |
| E14 | Second Floor UPS System          |
| E15 | Third Floor UPS System           |
| E16 | Fourth Floor UPS System          |
| E17 | Ground Floor AC & Vents System   |
| E18 | First Floor AC & Vents System    |
| E19 | Second Floor AC & Vents System   |
| E20 | Third Floor AC & Vents System    |
| E21 | Fourth Floor AC & Vents System   |
| E22 | Ground Floor Low Voltage Systems |
| E23 | First Floor Low Voltage Systems  |

|     |                                       |
|-----|---------------------------------------|
| E24 | Second Floor Low Voltage Systems      |
| E25 | Third Floor Low Voltage Systems       |
| E26 | Fourth Floor Low Voltage Systems      |
| E27 | Ground Floor Fire Alarm System        |
| E28 | First Floor Fire Alarm System         |
| E29 | Second Floor Fire Alarm System        |
| E30 | Third Floor Fire Alarm System         |
| E31 | Fourth Floor Fire Alarm System        |
| E32 | Ground Floor CCTV & Sound Systems     |
| E33 | First Floor CCTV & Sound Systems      |
| E34 | Second Floor CCTV & Sound Systems     |
| E35 | Third Floor CCTV & Sound Systems      |
| E36 | Fourth Floor CCTV & Sound Systems     |
| E37 | Flood Lights on the Roof              |
| E38 | Meeting Room Projector Details        |
| E39 | Server Room Access Control System - 1 |
| E40 | Server Room Access Control System - 2 |
| E41 | Site Plan                             |
| E42 | Lightning System Details              |
| E43 | Electrical Distribution Boards 1      |
| E44 | Electrical Distribution Boards 2      |
| E45 | Electrical Distribution Boards 3      |
| E46 | Electrical Distribution Boards 4      |
|     |                                       |

REVISION A :

Name: \_\_\_\_\_

Date : \_\_\_\_\_

Remarks: \_\_\_\_\_

\_\_\_\_\_

\_\_\_\_\_

\_\_\_\_\_

\_\_\_\_\_

\_\_\_\_\_

\_\_\_\_\_

REVISION B :

Name: \_\_\_\_\_

Date : \_\_\_\_\_

Remarks: \_\_\_\_\_

\_\_\_\_\_

\_\_\_\_\_

\_\_\_\_\_

\_\_\_\_\_

\_\_\_\_\_

\_\_\_\_\_



القسم للخدمة  
الالكتروميكانيكية  
رام الله - شارع محطة الصلح  
عمارة الميناء - الطابق الرابع  
تلفاكس ٩٠٧٧٧٧٧

DESIGNED BY : Amant An-Nasser  
CHECKED BY : Pius Gith  
DRAWN BY : Amant An-Nasser

FJPU

TITLE:

Title

OWNER :

Drawing No. EO

SCALE DATE  
1:100 26/11/2015

|     |                                  |
|-----|----------------------------------|
| E0  | Title                            |
| E1  | Legend                           |
| E2  | Ground Floor Lighting System     |
| E3  | First Floor Lighting System      |
| E4  | Second Floor Lighting System     |
| E5  | Third Floor Lighting System      |
| E6  | Fourth Floor Lighting System     |
| E7  | Ground Floor Power System        |
| E8  | First Floor Power System         |
| E9  | Second Floor Power System        |
| E10 | Third Floor Power System         |
| E11 | Fourth Floor Power System        |
| E12 | Ground Floor UPS System          |
| E13 | First Floor UPS System           |
| E14 | Second Floor UPS System          |
| E15 | Third Floor UPS System           |
| E16 | Fourth Floor UPS System          |
| E17 | Ground Floor AC & Vents System   |
| E18 | First Floor AC & Vents System    |
| E19 | Second Floor AC & Vents System   |
| E20 | Third Floor AC & Vents System    |
| E21 | Fourth Floor AC & Vents System   |
| E22 | Ground Floor Low Voltage Systems |
| E23 | First Floor Low Voltage Systems  |

|     |                                       |
|-----|---------------------------------------|
| E24 | Second Floor Low Voltage Systems      |
| E25 | Third Floor Low Voltage Systems       |
| E26 | Fourth Floor Low Voltage Systems      |
| E27 | Ground Floor Fire Alarm System        |
| E28 | First Floor Fire Alarm System         |
| E29 | Second Floor Fire Alarm System        |
| E30 | Third Floor Fire Alarm System         |
| E31 | Fourth Floor Fire Alarm System        |
| E32 | Ground Floor CCTV & Sound Systems     |
| E33 | First Floor CCTV & Sound Systems      |
| E34 | Second Floor CCTV & Sound Systems     |
| E35 | Third Floor CCTV & Sound Systems      |
| E36 | Fourth Floor CCTV & Sound Systems     |
| E37 | Flood Lights on the Roof              |
| E38 | Meeting Room Projector Details        |
| E39 | Server Room Access Control System - 1 |
| E40 | Server Room Access Control System - 2 |
| E41 | Site Plan                             |
| E42 | Lightning System Details              |
| E43 | Electrical Distribution Boards 1      |
| E44 | Electrical Distribution Boards 2      |
| E45 | Electrical Distribution Boards 3      |
| E46 | Electrical Distribution Boards 4      |
|     |                                       |

REVISION A :

Name: \_\_\_\_\_

Date : \_\_\_\_\_

Remarks: \_\_\_\_\_

\_\_\_\_\_

\_\_\_\_\_

\_\_\_\_\_

\_\_\_\_\_

\_\_\_\_\_

\_\_\_\_\_

REVISION B :

Name: \_\_\_\_\_

Date : \_\_\_\_\_

Remarks: \_\_\_\_\_

\_\_\_\_\_

\_\_\_\_\_

\_\_\_\_\_

\_\_\_\_\_

\_\_\_\_\_

\_\_\_\_\_



القسم للخدمة  
الالكترونيكا نيكية  
رام الله - شارع محطة الصلح  
صالة المينتين - الطابق الرابع  
تلفاكي ٩٧٧٧٧٧٧

DESIGNED BY : Amant An-Nasser  
CHECKED BY : Pius Geth  
DRAWN BY : Amant An-Nasser

FJPU



TITLE:

Title

OWNER :

Drawing No. EO

SCALE DATE  
1:100 26/11/2015

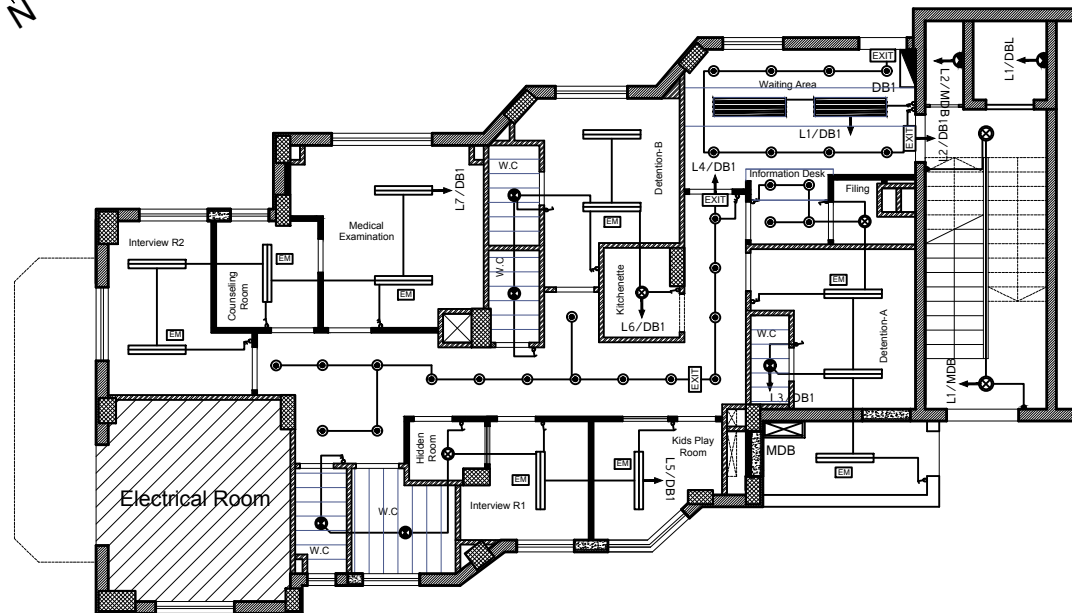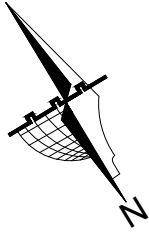

REVISION A :

Name: \_\_\_\_\_

Date : \_\_\_\_\_

Remarks: \_\_\_\_\_

REVISION B :

Name: \_\_\_\_\_

Date : \_\_\_\_\_

Remarks: \_\_\_\_\_



القطاع الصحي  
الالكترونيكا  
رام الله - شارع جامعة الملك  
صالة الميراث - الطابق الرابع  
تلفون ٩٠٠٠٠٠٠٠

DESIGNED BY : Amant An-Nasser  
CHECKED BY : Pinar Geli  
DRAWN BY : Amant An-Nasser



FJPU

TITLE:  
Ground Floor  
Lighting System

OWNER :

Drawing No. E2

SCALE 1:100  
DATE 26/11/2015

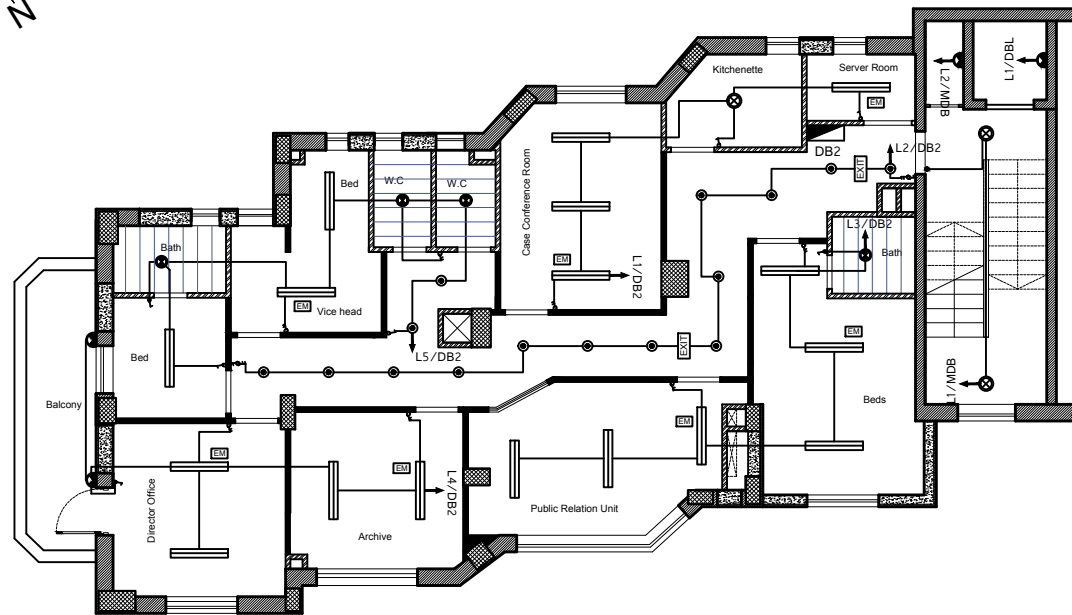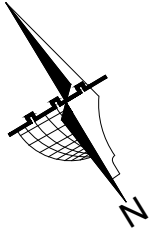

REVISION A :

Name: \_\_\_\_\_

Date : \_\_\_\_\_

Remarks: \_\_\_\_\_

\_\_\_\_\_

\_\_\_\_\_

\_\_\_\_\_

\_\_\_\_\_

\_\_\_\_\_

REVISION B :

Name: \_\_\_\_\_

Date : \_\_\_\_\_

Remarks: \_\_\_\_\_

\_\_\_\_\_

\_\_\_\_\_

\_\_\_\_\_

\_\_\_\_\_

\_\_\_\_\_



القسم للخدمة  
الالكتروميكانيكية  
رام الله - شارع مستشفى الصليح  
عمارة المينتين - الطابق الرابع  
تلفون ٩٠٧٧٧٧٦

DESIGNED BY : Amant An-Nasser  
CHECKED BY : Pinus Geth  
DRAWN BY : Amant An-Nasser


FJPU

TITLE:  
First Floor  
Lighting System


OWNER :



Drawing No. E3

SCALE DATE  
1:100 26/11/2015

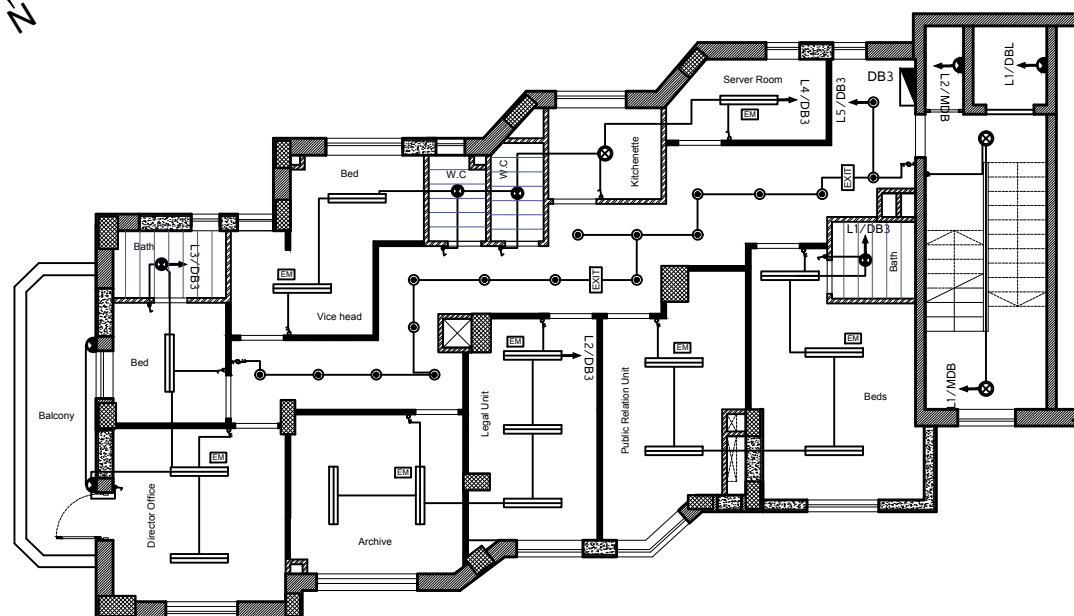

|       |            |
|-------|------------|
| 1:100 | 26/11/2015 |
|-------|------------|

 

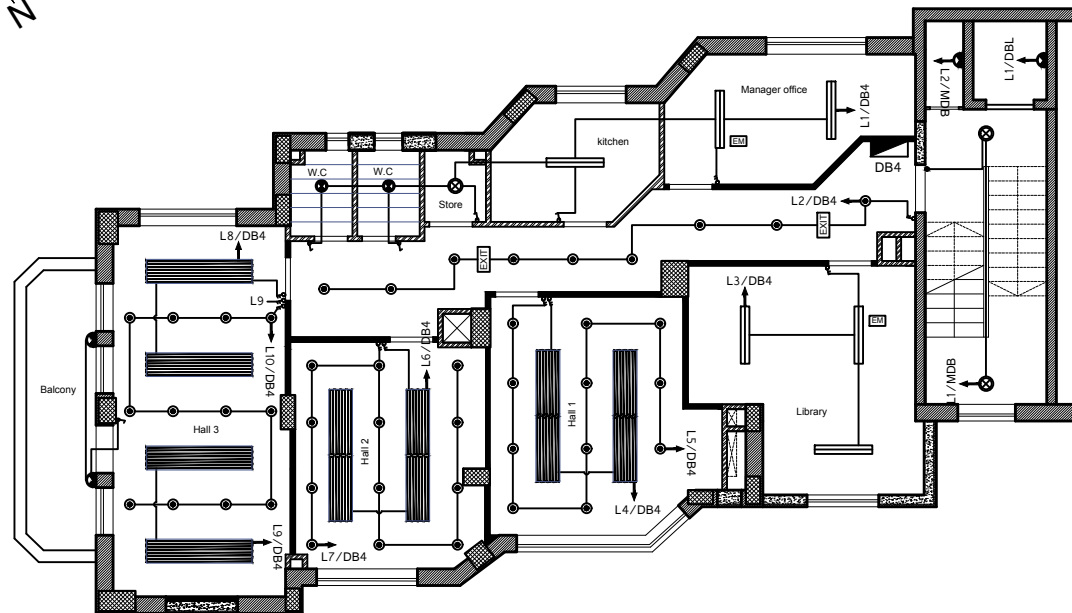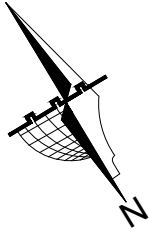

REVISION A :

Name: \_\_\_\_\_

Date : \_\_\_\_\_

Remarks: \_\_\_\_\_

\_\_\_\_\_

\_\_\_\_\_

\_\_\_\_\_

\_\_\_\_\_

\_\_\_\_\_

\_\_\_\_\_

REVISION B :

Name: \_\_\_\_\_

Date : \_\_\_\_\_

Remarks: \_\_\_\_\_

\_\_\_\_\_

\_\_\_\_\_

\_\_\_\_\_

\_\_\_\_\_

\_\_\_\_\_

\_\_\_\_\_



الجامعة  
الالكترونية  
رام الله - شارع جامعة الملك  
عبدالله الثاني - الطابق الرابع  
تلفون ٩٠٠٠٠٠٠٠

DESIGNED BY : Amant An-Nasser  
CHECKED BY : Pius Geth  
DRAWN BY : Amant An-Nasser


FJPU

TITLE:  
Third Floor  
Lighting System

OWNER :


Drawing No. E5



SCALE 1:100 DATE 26/11/2015

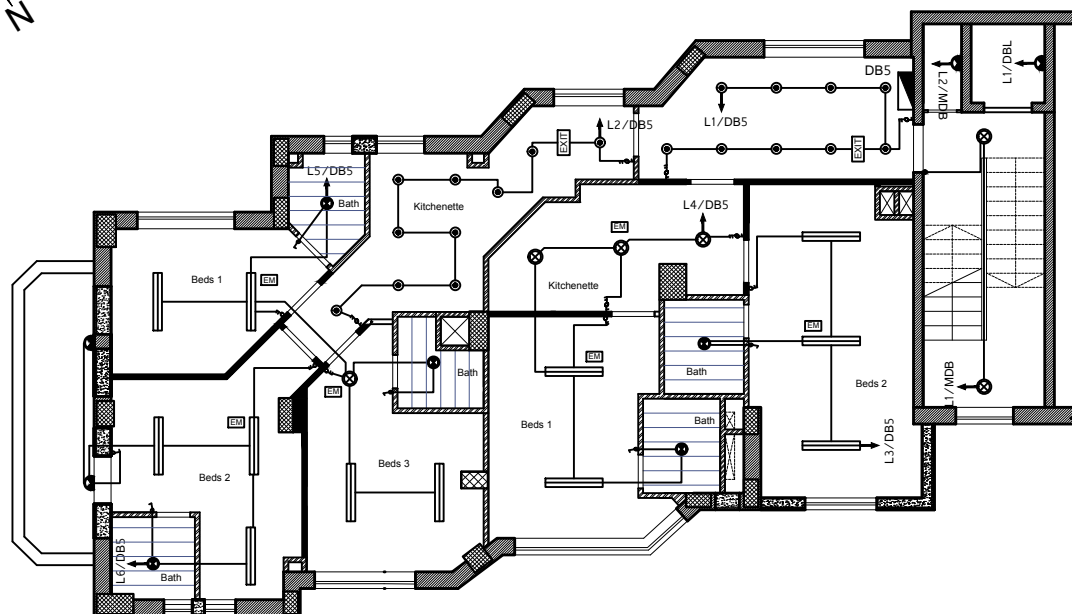

|  |  |
|--|--|
|  |  |
|--|--|

|  |  |
|--|--|
|  |  |
|--|--|

 

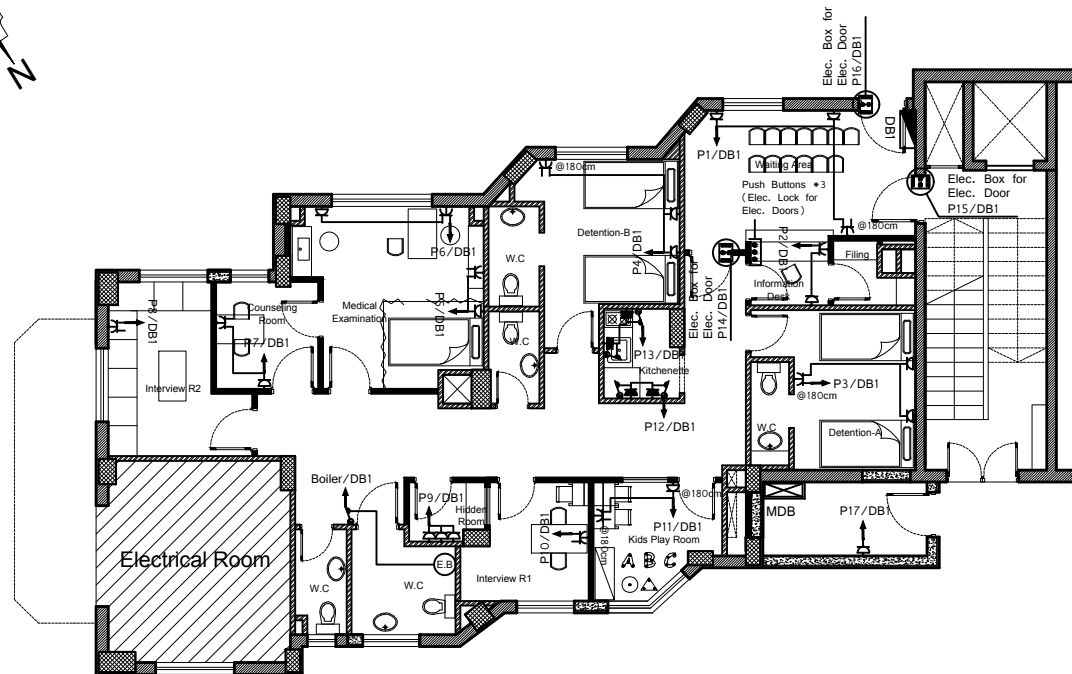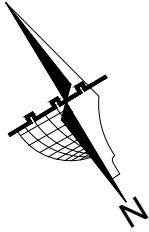

REVISION A :

Name: \_\_\_\_\_

Date : \_\_\_\_\_

Remarks: \_\_\_\_\_

\_\_\_\_\_

\_\_\_\_\_

\_\_\_\_\_

\_\_\_\_\_

\_\_\_\_\_

\_\_\_\_\_

REVISION B :

Name: \_\_\_\_\_

Date : \_\_\_\_\_

Remarks: \_\_\_\_\_

\_\_\_\_\_

\_\_\_\_\_

\_\_\_\_\_

\_\_\_\_\_

\_\_\_\_\_

\_\_\_\_\_



السلطان للخدمة  
الالكترونيكا نيكية  
رام الله - شارع محطة الصلح  
عمارة الميراني - الطابق الرابع  
تلفاخي ٩٠٧٧٧٧٧

DESIGNED BY : Amant An-Nasser  
CHECKED BY : Pirus Geth  
DRAWN BY : Amant An-Nasser



FJPU

TITLE:  
Ground Floor  
Power System

OWNER :

Drawing No. E7

SCALE DATE  
1:100 26/11/2015

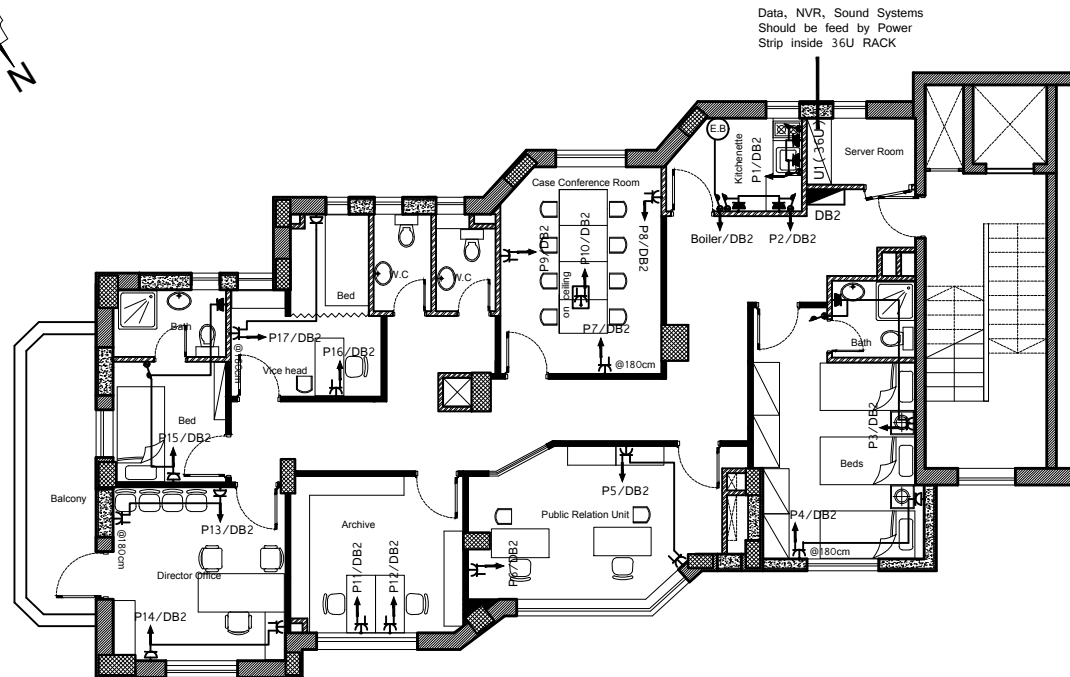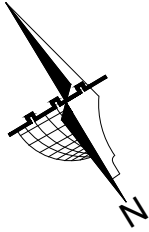

REVISION A :

Name: \_\_\_\_\_

Date : \_\_\_\_\_

Remarks: \_\_\_\_\_

\_\_\_\_\_

\_\_\_\_\_

\_\_\_\_\_

\_\_\_\_\_

\_\_\_\_\_

\_\_\_\_\_

REVISION B :

Name: \_\_\_\_\_

Date : \_\_\_\_\_

Remarks: \_\_\_\_\_

\_\_\_\_\_

\_\_\_\_\_

\_\_\_\_\_

\_\_\_\_\_

\_\_\_\_\_

\_\_\_\_\_



المستشفى للخدمة  
الإلكترونية  
رام الله - شارع جامعة الملك  
عصافه المينتي - الطريق الرابع  
تلفون ٣٣٣٣٣٣٣

DESIGNED BY : Amant An-Nasser  
CHECKED BY : Pius Geth  
DRAWN BY : Amant An-Nasser



FJPU

TITLE:  
First Floor  
Power System

OWNER :

Drawing No. E8

SCALE DATE  
1:100 26/11/2015

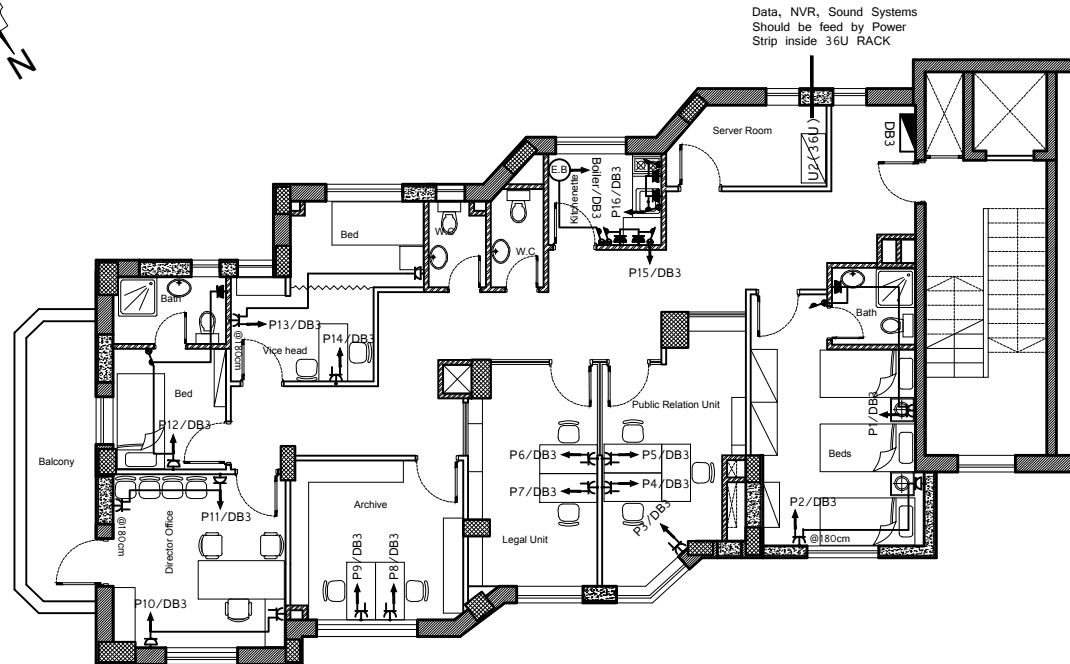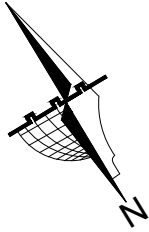

REVISION A :

Name: \_\_\_\_\_

Date : \_\_\_\_\_

Remarks: \_\_\_\_\_

REVISION B :

Name: \_\_\_\_\_

Date : \_\_\_\_\_

Remarks: \_\_\_\_\_



المستشفى للخدمة  
الإلكترونية  
رام الله - شارع جامعة الملك  
عصادة المهندس - الطريق الرابع  
تلفون ٠١١١١١١١١

DESIGNED BY : Amant An-Nasser  
CHECKED BY : Pinar Geli  
DRAWN BY : Amant An-Nasser



FJPU

TITLE:  
Second Floor  
Power System

OWNER :

Drawing No. E9

SCALE DATE  
1:100 26/11/2015

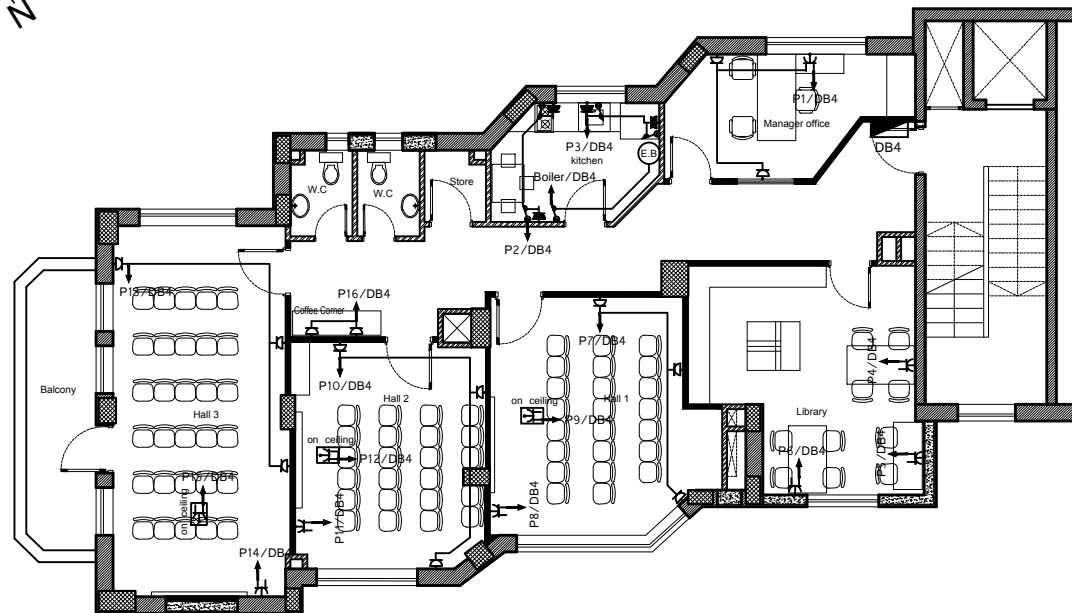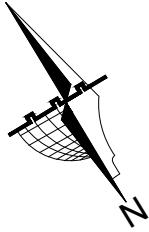

REVISION A :

Name: \_\_\_\_\_

Date : \_\_\_\_\_

Remarks: \_\_\_\_\_

\_\_\_\_\_

\_\_\_\_\_

\_\_\_\_\_

\_\_\_\_\_

\_\_\_\_\_

REVISION B :

Name: \_\_\_\_\_

Date : \_\_\_\_\_

Remarks: \_\_\_\_\_

\_\_\_\_\_

\_\_\_\_\_

\_\_\_\_\_

\_\_\_\_\_

\_\_\_\_\_



القطاع للتعليم  
الالكترونيكا  
رام الله - شارع جامعة الملك  
عصافه الجديدي - الطابق الرابع  
تلفون ٩٠٠٠٠٠٠٠

DESIGNED BY : Amant An-Nasser  
CHECKED BY : Pirus Geth  
DRAWN BY : Amant An-Nasser



FJPU

TITLE:  
Third Floor  
Power System

OWNER :

Drawing No. E10

SCALE DATE  
1:100 26/11/2015

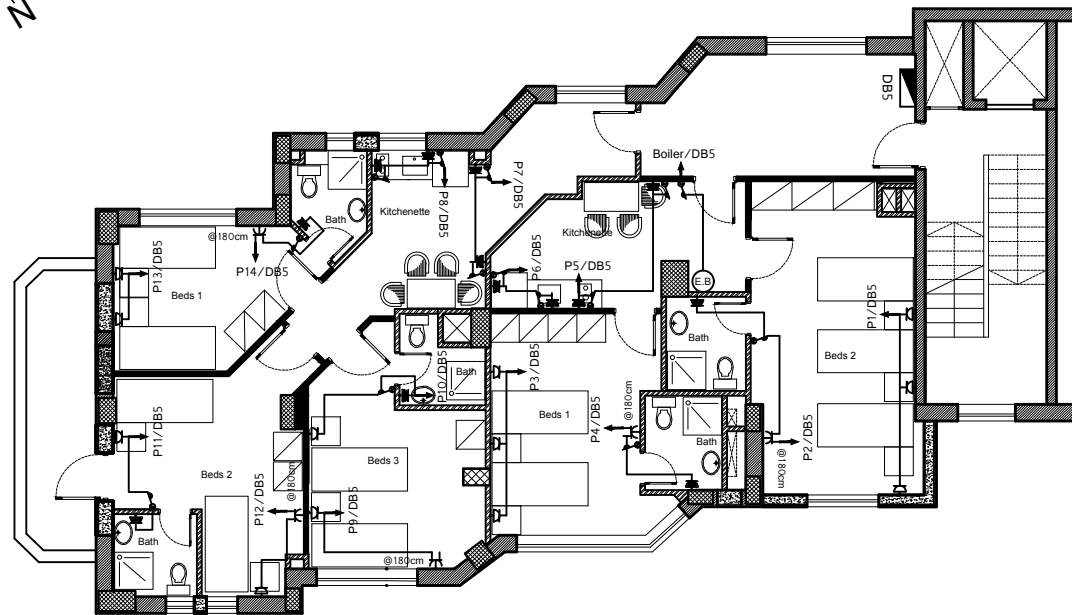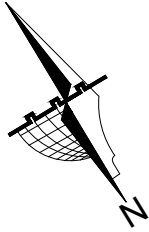

REVISION A :

Name: \_\_\_\_\_

Date : \_\_\_\_\_

Remarks: \_\_\_\_\_

\_\_\_\_\_

\_\_\_\_\_

\_\_\_\_\_

\_\_\_\_\_

\_\_\_\_\_

REVISION B :

Name: \_\_\_\_\_

Date : \_\_\_\_\_

Remarks: \_\_\_\_\_

\_\_\_\_\_

\_\_\_\_\_

\_\_\_\_\_

\_\_\_\_\_

\_\_\_\_\_



القسم للخدمة  
الالكترونيكا نيكية  
رام الله - شارع محطة الصلح  
عمارة الميراني - الطابق الرابع  
تلفون ٩٠٧٧٧٧٧

DESIGNED BY : Amant An-Nasser  
CHECKED BY : Pinus Geth  
DRAWN BY : Amant An-Nasser



*FJPU*

TITLE:  
Fourth Floor  
Power System

OWNER :

|             |     |
|-------------|-----|
| Drawing No. | E11 |
|-------------|-----|

|       |            |
|-------|------------|
| SCALE | DATE       |
| 1:100 | 26/11/2015 |

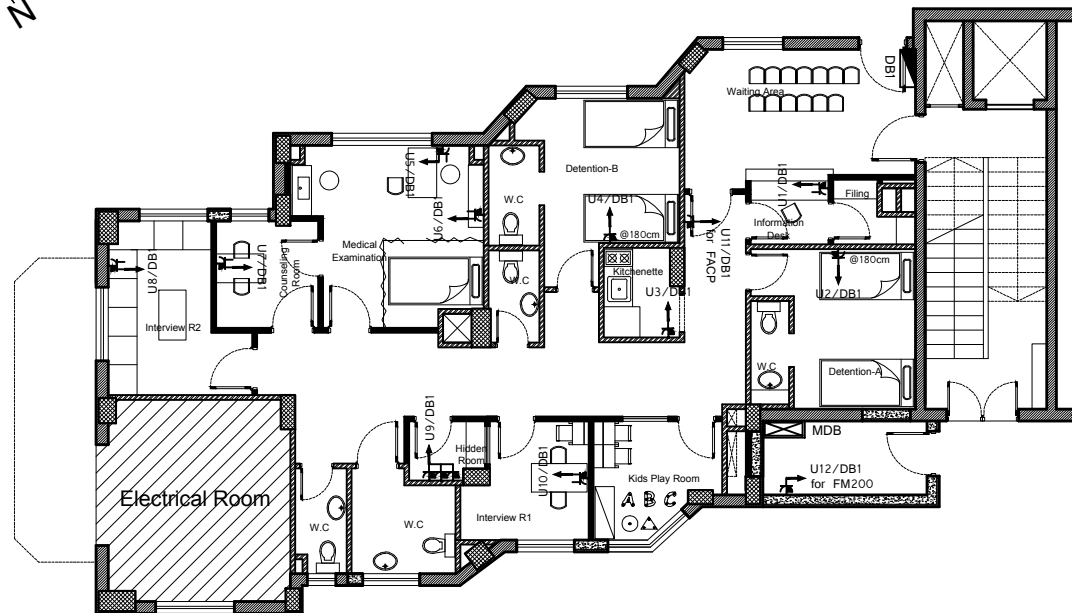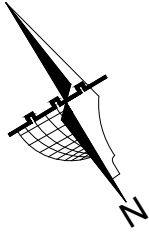

REVISION A :

Name: \_\_\_\_\_

Date : \_\_\_\_\_

Remarks: \_\_\_\_\_

\_\_\_\_\_

\_\_\_\_\_

\_\_\_\_\_

\_\_\_\_\_

\_\_\_\_\_

\_\_\_\_\_

REVISION B :

Name: \_\_\_\_\_

Date : \_\_\_\_\_

Remarks: \_\_\_\_\_

\_\_\_\_\_

\_\_\_\_\_

\_\_\_\_\_

\_\_\_\_\_

\_\_\_\_\_

\_\_\_\_\_



القسم للخدمة  
الإلكترونيكا نيكية  
رام الله - شارع محطة الصلح  
عمارة الميناء - الطابق الرابع  
تلفون ٩٠٧٧٧٧٧

DESIGNED BY : Amant An-Nasser  
CHECKED BY : Pinus Geth  
DRAWN BY : Amant An-Nasser



FJPU

TITLE:  
Ground Floor  
VPS System

OWNER :

Drawing No. E12

SCALE DATE  
1:100 26/11/2015

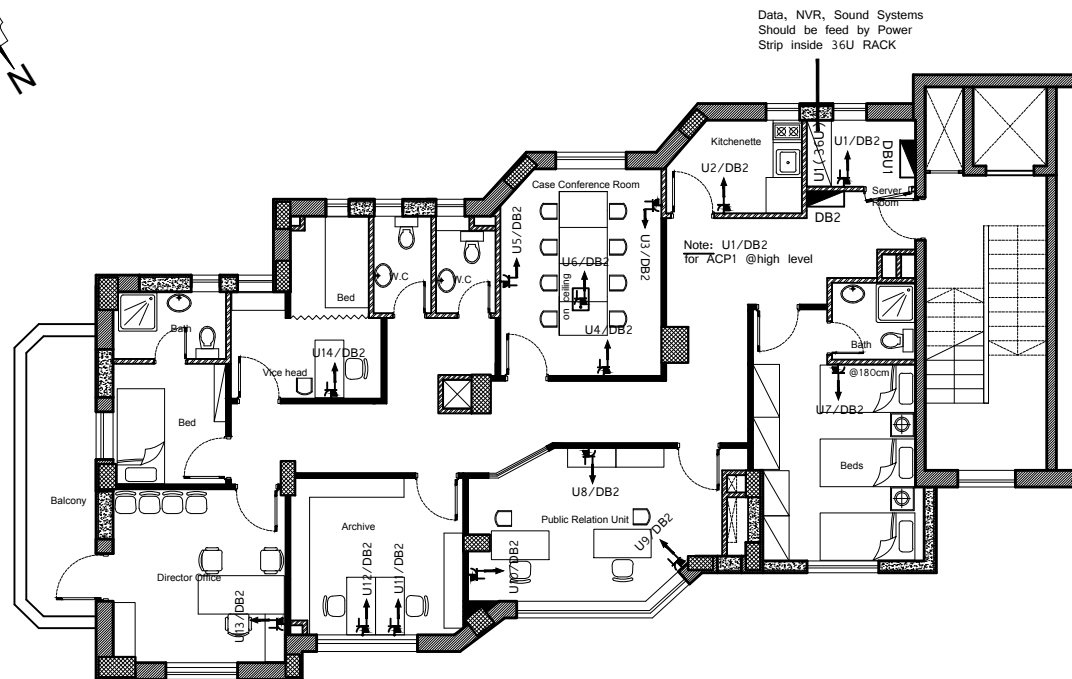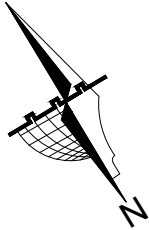

REVISION A :

Name: \_\_\_\_\_

Date : \_\_\_\_\_

Remarks: \_\_\_\_\_

\_\_\_\_\_

\_\_\_\_\_

\_\_\_\_\_

\_\_\_\_\_

\_\_\_\_\_

\_\_\_\_\_

REVISION B :

Name: \_\_\_\_\_

Date : \_\_\_\_\_

Remarks: \_\_\_\_\_

\_\_\_\_\_

\_\_\_\_\_

\_\_\_\_\_

\_\_\_\_\_

\_\_\_\_\_

\_\_\_\_\_



المستشار للخدمة  
الالكتروميكانيكية  
رام الله - شارع محطة الصلح  
عمارة الميراني - الطابق الرابع  
تلفون ٩٠٧٧٧٧٧

DESIGNED BY : Amant An-Nasser  
CHECKED BY : Pinus Geth  
DRAWN BY : Amant An-Nasser



FJPU

TITLE:  
First Floor  
UPS System

OWNER :

Drawing No. E13

SCALE DATE  
1:100 26/11/2015

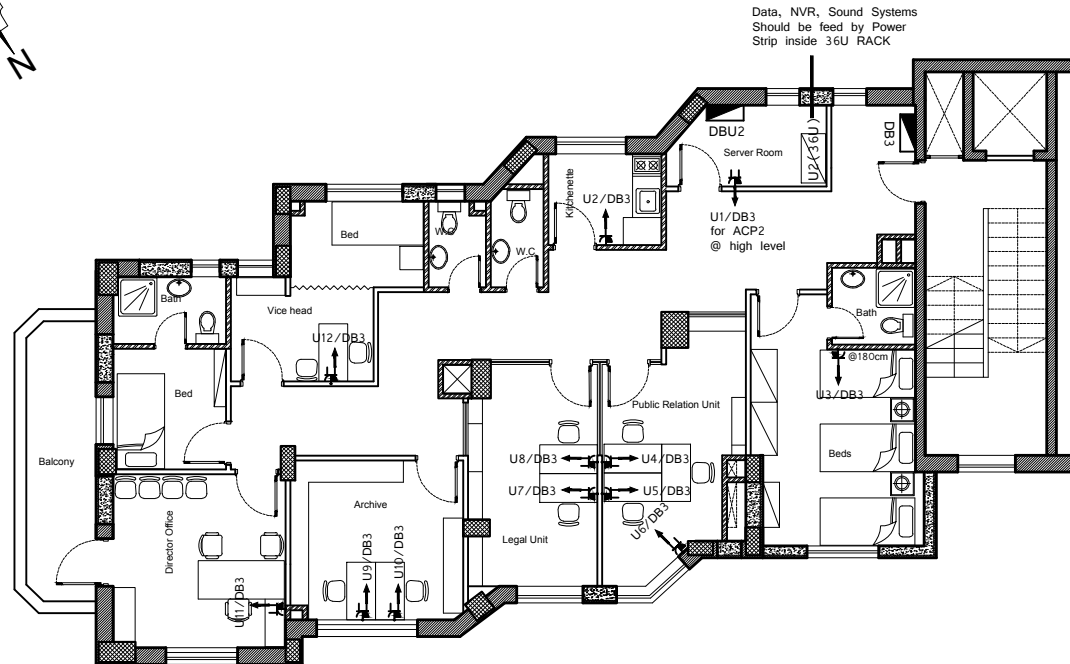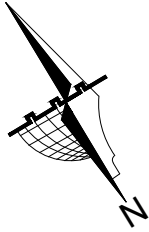

REVISION A :

Name: \_\_\_\_\_

Date : \_\_\_\_\_

Remarks: \_\_\_\_\_

REVISION B :

Name: \_\_\_\_\_

Date : \_\_\_\_\_

Remarks: \_\_\_\_\_



القطاع للصحة  
الإلكترونية  
رام الله - شارع جامعة الملك  
عصارة الميناء - الطابق الرابع  
تلفون ٩٠٠٠٠٠٠٠

DESIGNED BY : Amant An-Nasser  
CHECKED BY : Pius Geth  
DRAWN BY : Amant An-Nasser



FJPU

TITLE:  
Second Floor  
UPS System

OWNER :

Drawing No. E14

SCALE DATE  
1:100 26/11/2015

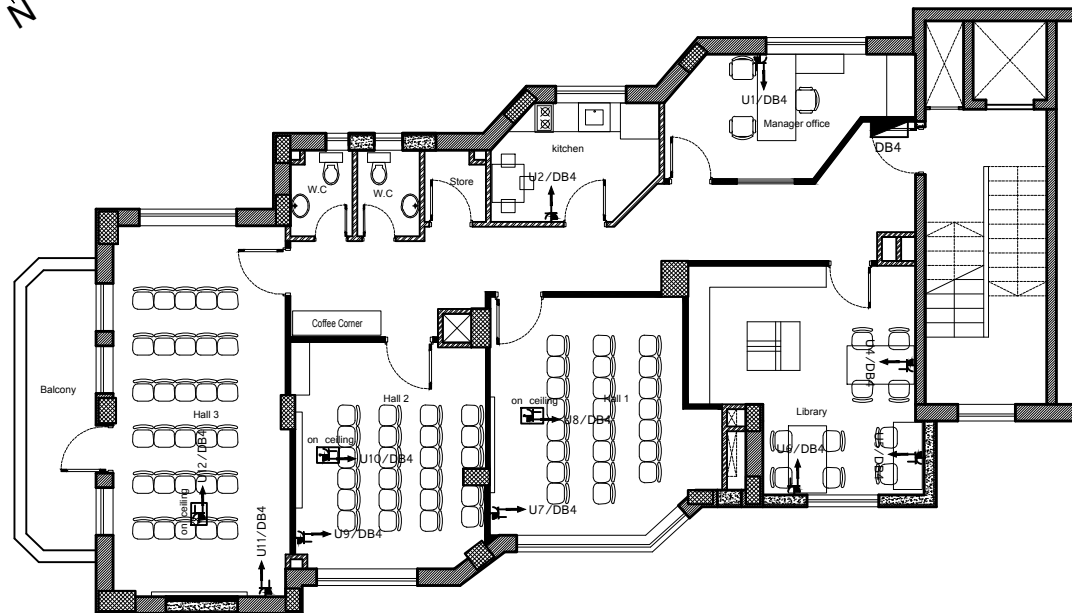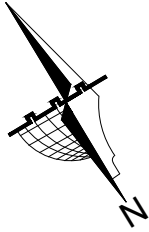

REVISION A :

Name: \_\_\_\_\_

Date : \_\_\_\_\_

Remarks: \_\_\_\_\_

\_\_\_\_\_

\_\_\_\_\_

\_\_\_\_\_

\_\_\_\_\_

\_\_\_\_\_

REVISION B :

Name: \_\_\_\_\_

Date : \_\_\_\_\_

Remarks: \_\_\_\_\_

\_\_\_\_\_

\_\_\_\_\_

\_\_\_\_\_

\_\_\_\_\_

\_\_\_\_\_



القسم للخدمة  
الإلكترونيكية  
رام الله - شارع محطة الصلح  
عمارة الميناء - الطابق الرابع  
تلفون ٣٣١١٧٧٦

DESIGNED BY : Amant An-Nasser  
CHECKED BY : Pinus Geth  
DRAWN BY : Amant An-Nasser



FJPU

TITLE:  
Third Floor  
UPS System

OWNER :

Drawing No. E15

SCALE DATE  
1:100 26/11/2015

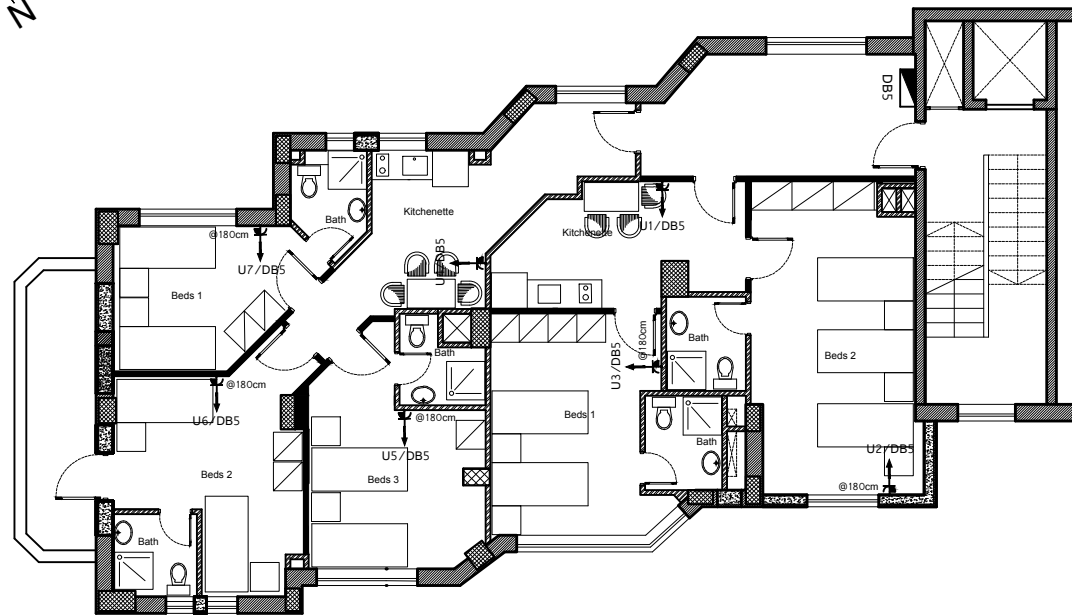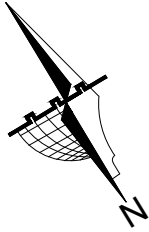

REVISION A :

Name: \_\_\_\_\_

Date : \_\_\_\_\_

Remarks: \_\_\_\_\_

\_\_\_\_\_

\_\_\_\_\_

\_\_\_\_\_

\_\_\_\_\_

\_\_\_\_\_

REVISION B :

Name: \_\_\_\_\_

Date : \_\_\_\_\_

Remarks: \_\_\_\_\_

\_\_\_\_\_

\_\_\_\_\_

\_\_\_\_\_

\_\_\_\_\_

\_\_\_\_\_



المسجل للخدمة  
الالكتروميكانيكية  
رام الله - شارع محطة الصلح  
عمارة الميراني - الطابق الرابع  
تلفون ٩٧٧٧٧٧٧

DESIGNED BY : Amant An-Nasser  
CHECKED BY : Pinus Geth  
DRAWN BY : Amant An-Nasser



FJPU

TITLE:  
Fourth Floor  
UPS System

OWNER :

Drawing No. E16

SCALE DATE  
1:100 26/11/2015

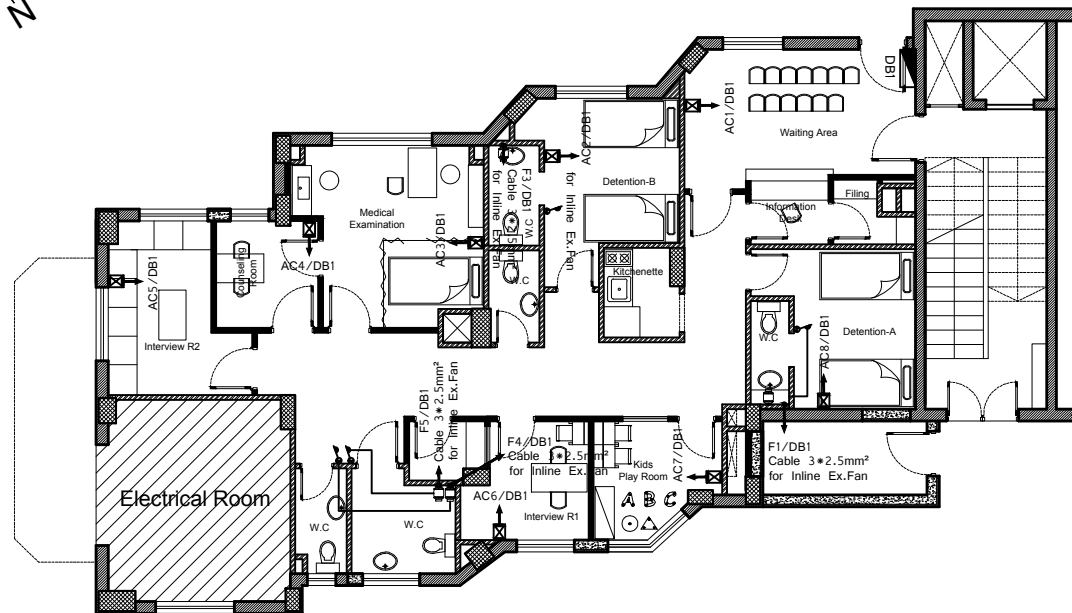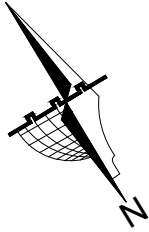

REVISION A :

Name: \_\_\_\_\_

Date : \_\_\_\_\_

Remarks: \_\_\_\_\_

\_\_\_\_\_

\_\_\_\_\_

\_\_\_\_\_

\_\_\_\_\_

\_\_\_\_\_

\_\_\_\_\_

REVISION B :

Name: \_\_\_\_\_

Date : \_\_\_\_\_

Remarks: \_\_\_\_\_

\_\_\_\_\_

\_\_\_\_\_

\_\_\_\_\_

\_\_\_\_\_

\_\_\_\_\_

\_\_\_\_\_



السلطة للخدمة  
الالكترونيكية  
رام الله - شارع محطة الصلح  
عمارة الميناء - الطابق الرابع  
تلفون ٩٠٠٠٠٠٠٠

DESIGNED BY : Amant An-Nasser  
CHECKED BY : Pius Geth  
DRAWN BY : Amant An-Nasser



FJPU

TITLE:  
Ground Floor  
AC & Vents System

OWNER :

Drawing No. E17

SCALE 1:100 DATE 26/11/2015

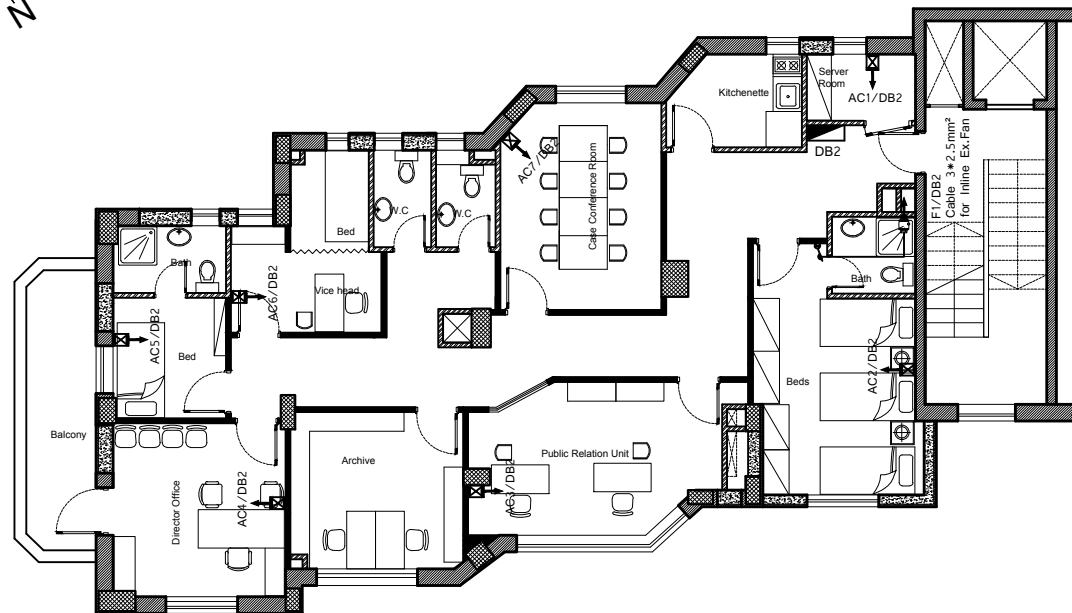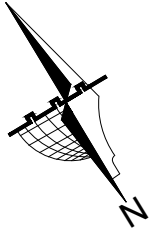

REVISION A :

Name: \_\_\_\_\_

Date : \_\_\_\_\_

Remarks: \_\_\_\_\_

REVISION B :

Name: \_\_\_\_\_

Date : \_\_\_\_\_

Remarks: \_\_\_\_\_



القسم للخدمة  
الالكتروميكانيكية  
رام الله - شارع محطة الصلح  
عمارة المينتي - الطابق الرابع  
تلفون ٩٣٧٧٧٧٧

DESIGNED BY : Amant An-Nasser  
CHECKED BY : Pinus Geth  
DRAWN BY : Amant An-Nasser



FJPU

TITLE:  
First Floor  
AC & Vents System

OWNER :

Drawing No. E18

SCALE DATE  
1:100 26/11/2015

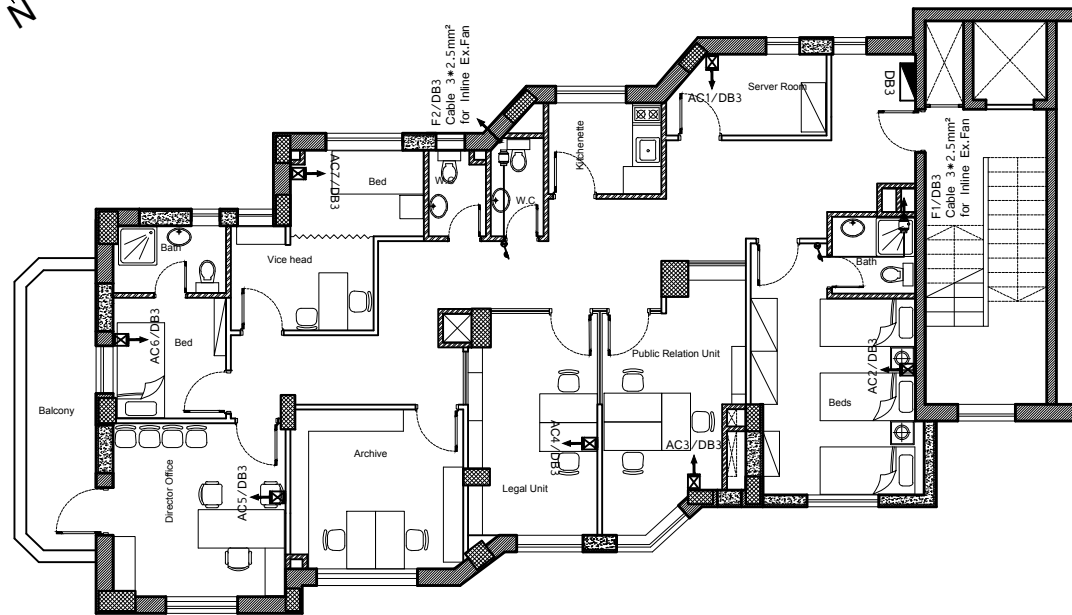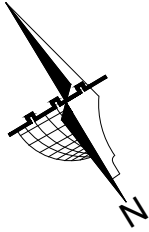

REVISION A :

Name: \_\_\_\_\_

Date : \_\_\_\_\_

Remarks: \_\_\_\_\_

\_\_\_\_\_

\_\_\_\_\_

\_\_\_\_\_

\_\_\_\_\_

\_\_\_\_\_

\_\_\_\_\_

REVISION B :

Name: \_\_\_\_\_

Date : \_\_\_\_\_

Remarks: \_\_\_\_\_

\_\_\_\_\_

\_\_\_\_\_

\_\_\_\_\_

\_\_\_\_\_

\_\_\_\_\_

\_\_\_\_\_



المستشفى  
الإلكترونيكا  
رام الله - شارع جامعة النجاح  
عمارة المبنى - الطابق الرابع  
تلفون ٩٠٠٠٠٠٠٠

DESIGNED BY : Amant An-Nasser  
CHECKED BY : Pinar Geli  
DRAWN BY : Amant An-Nasser



FJPU

TITLE:  
Second Floor  
AC & Vents System

OWNER :

Drawing No. E19

SCALE DATE  
1:100 26/11/2015

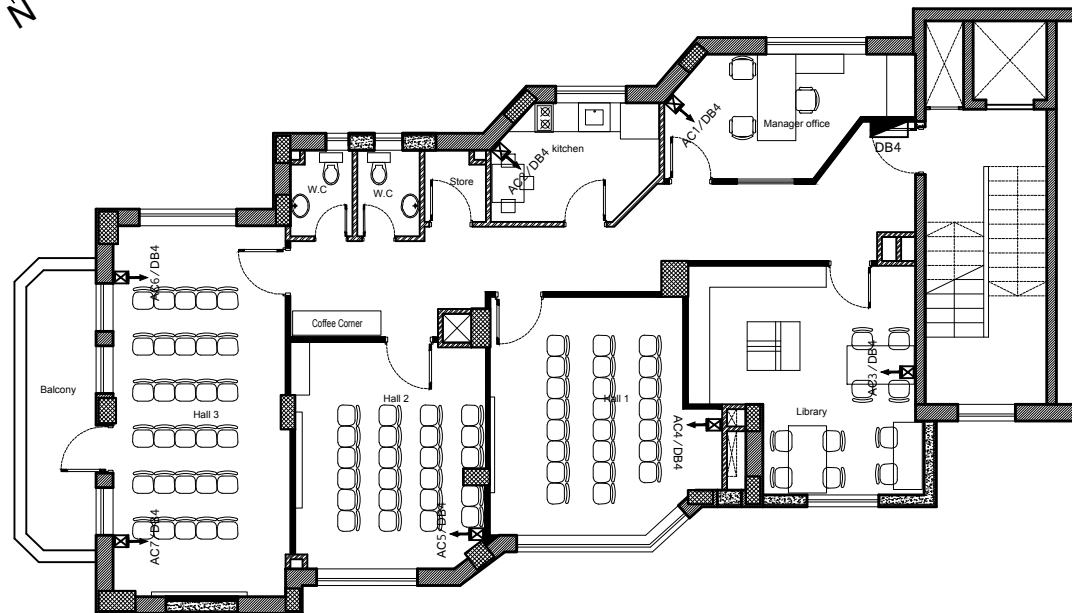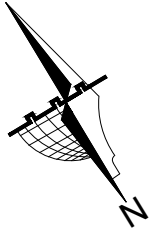

REVISION A :

Name: \_\_\_\_\_

Date : \_\_\_\_\_

Remarks: \_\_\_\_\_

\_\_\_\_\_

\_\_\_\_\_

\_\_\_\_\_

\_\_\_\_\_

\_\_\_\_\_

\_\_\_\_\_

REVISION B :

Name: \_\_\_\_\_

Date : \_\_\_\_\_

Remarks: \_\_\_\_\_

\_\_\_\_\_

\_\_\_\_\_

\_\_\_\_\_

\_\_\_\_\_

\_\_\_\_\_

\_\_\_\_\_



القسم الهندسي  
الالكترونيكا والكهرباء  
رام الله - شارع جامعة الصالح  
عمارة المهندس - الطابق الرابع  
تلفون ٩٧٧٧٧٧٧

DESIGNED BY : Amant An-Nasser  
CHECKED BY : Pinus Geth  
DRAWN BY : Amant An-Nasser



FJPU

TITLE:  
Third Floor  
AC & Vents System

OWNER :

Drawing No. E20

SCALE DATE  
1:100 26/11/2015

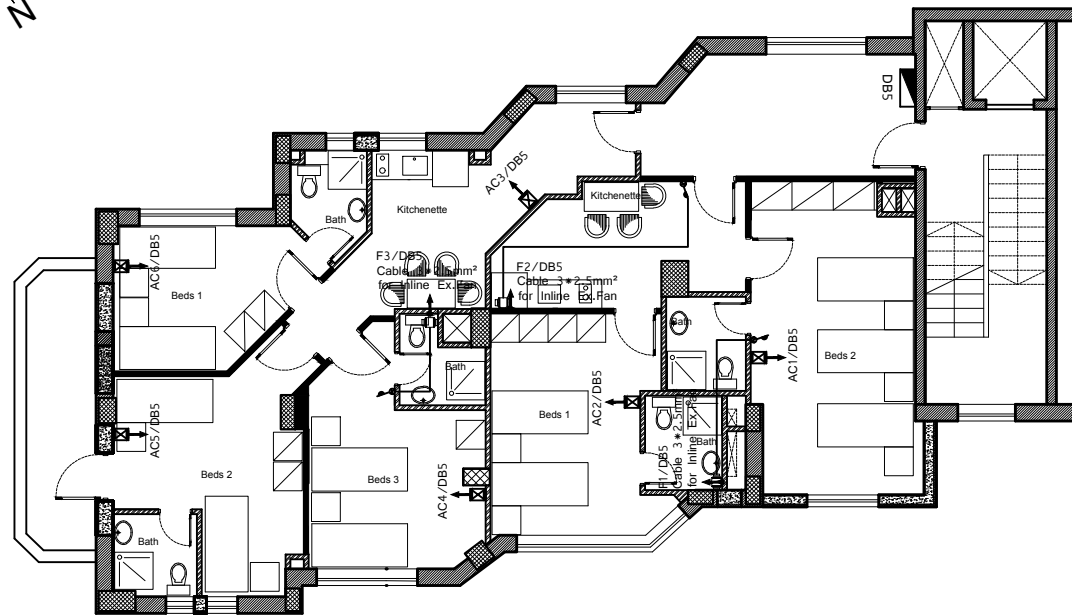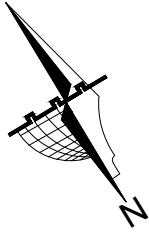

REVISION A :

Name: \_\_\_\_\_

Date : \_\_\_\_\_

Remarks: \_\_\_\_\_

\_\_\_\_\_

\_\_\_\_\_

\_\_\_\_\_

\_\_\_\_\_

\_\_\_\_\_

REVISION B :

Name: \_\_\_\_\_

Date : \_\_\_\_\_

Remarks: \_\_\_\_\_

\_\_\_\_\_

\_\_\_\_\_

\_\_\_\_\_

\_\_\_\_\_

\_\_\_\_\_



المسجل للخدمة  
الالكترونيكا نيكية  
رام الله - شارع محطة الصلح  
عمارة الميراني - الطابق الرابع  
تلفون ٩٨٧٦٥٤٣٢١٠

DESIGNED BY : Amant An-Nasser  
CHECKED BY : Pirus Geth  
DRAWN BY : Amant An-Nasser



FJPU

TITLE:  
Fourth Floor  
AC & Vents System

OWNER :

Drawing No. E21

SCALE 1:100 DATE 26/11/2015

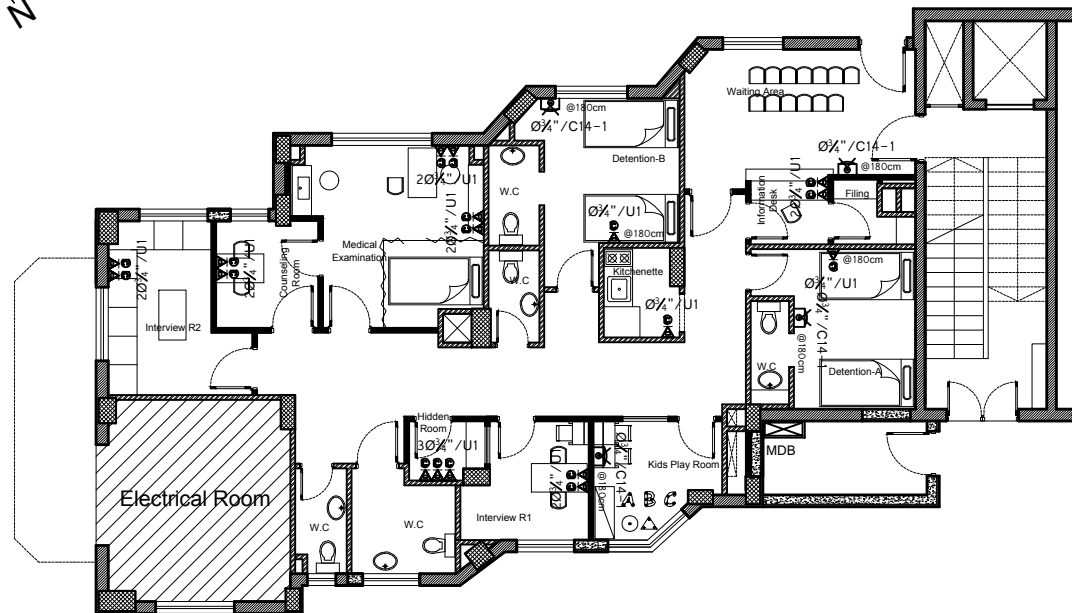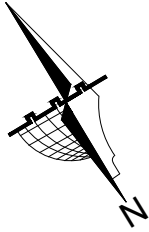

REVISION A :

Name: \_\_\_\_\_

Date : \_\_\_\_\_

Remarks: \_\_\_\_\_

\_\_\_\_\_

\_\_\_\_\_

\_\_\_\_\_

\_\_\_\_\_

\_\_\_\_\_

REVISION B :

Name: \_\_\_\_\_

Date : \_\_\_\_\_

Remarks: \_\_\_\_\_

\_\_\_\_\_

\_\_\_\_\_

\_\_\_\_\_

\_\_\_\_\_

\_\_\_\_\_



القسم للخدمة  
الكهربائية  
رام الله - شارع محطة الصلح  
عمارة الميناء - الطابق الرابع  
تلفون ٢٢٢٢٢٢٢

DESIGNED BY : Amant An-Nasser  
CHECKED BY : Pius Geth  
DRAWN BY : Amant An-Nasser



FJPU

TITLE:  
Ground Floor  
Low Voltage  
Systems

OWNER :

Drawing No. E22

SCALE DATE  
1:100 26/11/2015

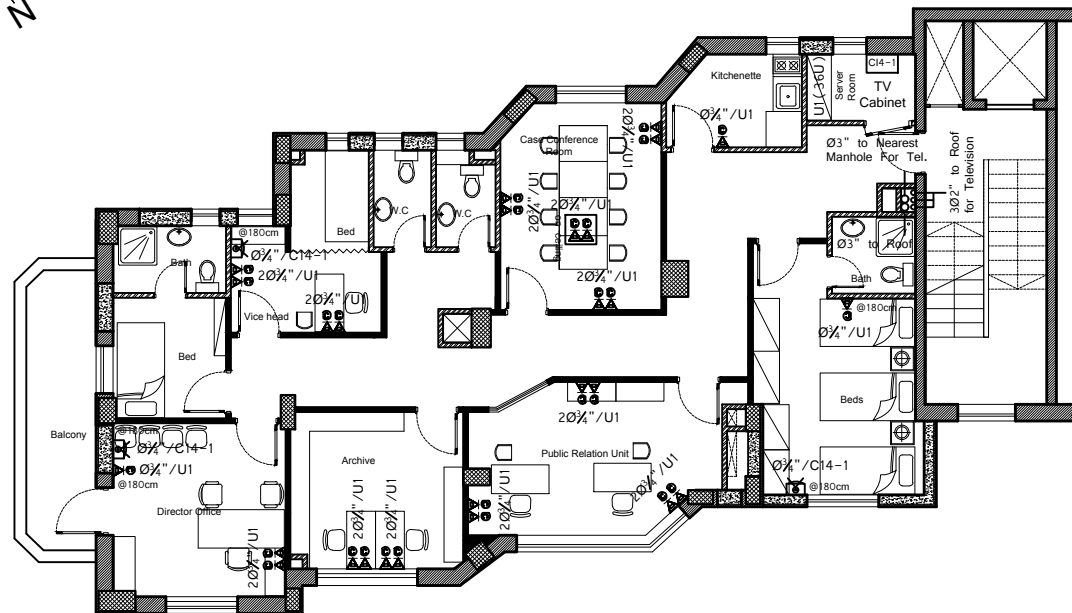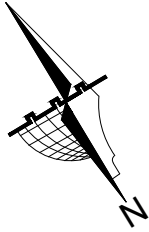

REVISION A :

Name: \_\_\_\_\_

Date : \_\_\_\_\_

Remarks: \_\_\_\_\_

\_\_\_\_\_

\_\_\_\_\_

\_\_\_\_\_

\_\_\_\_\_

\_\_\_\_\_

\_\_\_\_\_

REVISION B :

Name: \_\_\_\_\_

Date : \_\_\_\_\_

Remarks: \_\_\_\_\_

\_\_\_\_\_

\_\_\_\_\_

\_\_\_\_\_

\_\_\_\_\_

\_\_\_\_\_

\_\_\_\_\_



المستشفى للخدمة  
الالكتروميكانيكية  
رام الله - شارع محطة الصلح  
عمارة الميراني - الطابق الرابع  
تلفون ٧٠٧٧٧٧٧

DESIGNED BY : Amant An-Nasser  
CHECKED BY : Pinar Geli  
DRAWN BY : Amant An-Nasser



FJPU

TITLE:  
First Floor  
Low Voltage  
Systems

OWNER :

Drawing No. E23

SCALE DATE  
1:100 26/11/2015

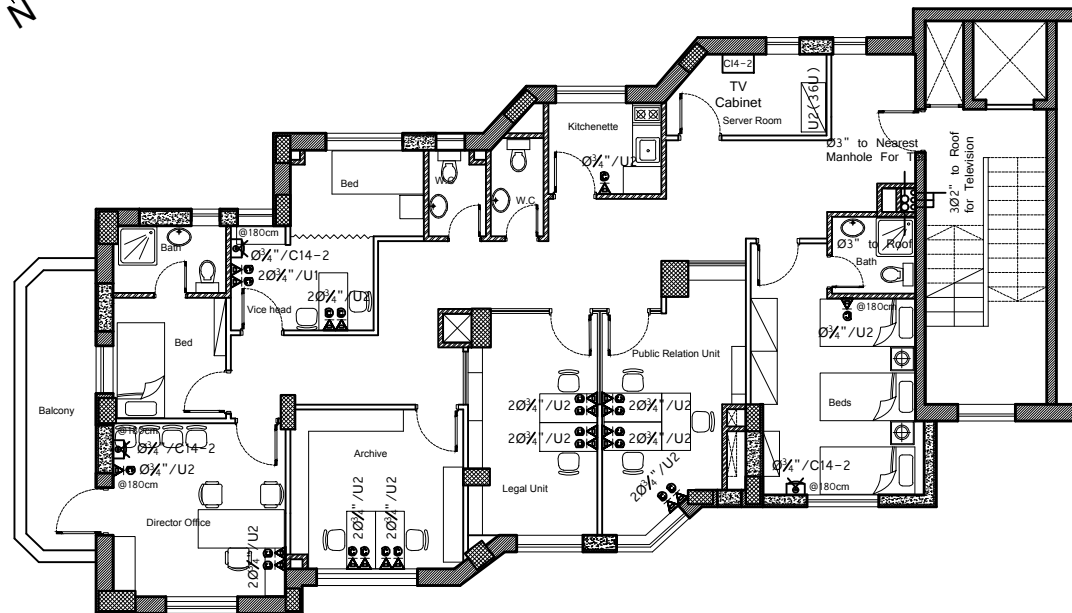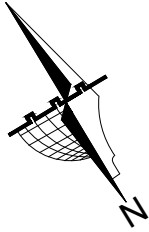

REVISION A :

Name: \_\_\_\_\_

Date : \_\_\_\_\_

Remarks: \_\_\_\_\_

\_\_\_\_\_

\_\_\_\_\_

\_\_\_\_\_

\_\_\_\_\_

\_\_\_\_\_

\_\_\_\_\_

REVISION B :

Name: \_\_\_\_\_

Date : \_\_\_\_\_

Remarks: \_\_\_\_\_

\_\_\_\_\_

\_\_\_\_\_

\_\_\_\_\_

\_\_\_\_\_

\_\_\_\_\_

\_\_\_\_\_



المجلس للخدمة  
الإلكترونية  
رام الله - شارع محطة الصلح  
عمارة الميناء - الطابق الرابع  
تلفون ٩٠٠٠٠٠٠٠

DESIGNED BY : Amant An-Nasser  
CHECKED BY : Pinar Geli  
DRAWN BY : Amant An-Nasser



FJPU

TITLE:  
Second Floor  
Low Voltage  
Systems

OWNER :

Drawing No. E24

SCALE DATE  
1:100 26/11/2015

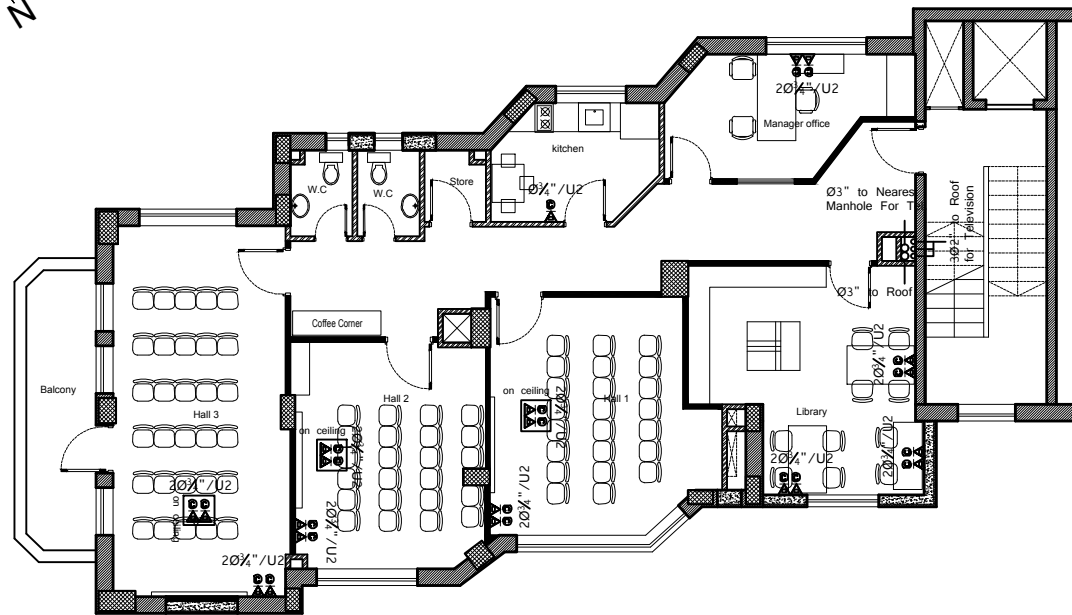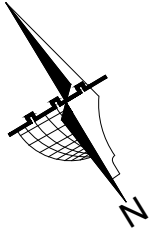

REVISION A :

Name: \_\_\_\_\_

Date : \_\_\_\_\_

Remarks: \_\_\_\_\_

\_\_\_\_\_

\_\_\_\_\_

\_\_\_\_\_

\_\_\_\_\_

\_\_\_\_\_

\_\_\_\_\_

REVISION B :

Name: \_\_\_\_\_

Date : \_\_\_\_\_

Remarks: \_\_\_\_\_

\_\_\_\_\_

\_\_\_\_\_

\_\_\_\_\_

\_\_\_\_\_

\_\_\_\_\_

\_\_\_\_\_



القسم للخدمة  
الالكتروميكانيكية  
رام الله - شارع محطة الصلح  
عمارة المينوتشي - الطابق الرابع  
تلفاكس ٣٣١١٧٣٦

DESIGNED BY : Amant An-Nasser  
CHECKED BY : Pinus Geth  
DRAWN BY : Amant An-Nasser



FJPU

TITLE:  
Third Floor  
Low Voltage  
Systems

OWNER :

Drawing No. E25

SCALE DATE  
1:100 26/11/2015

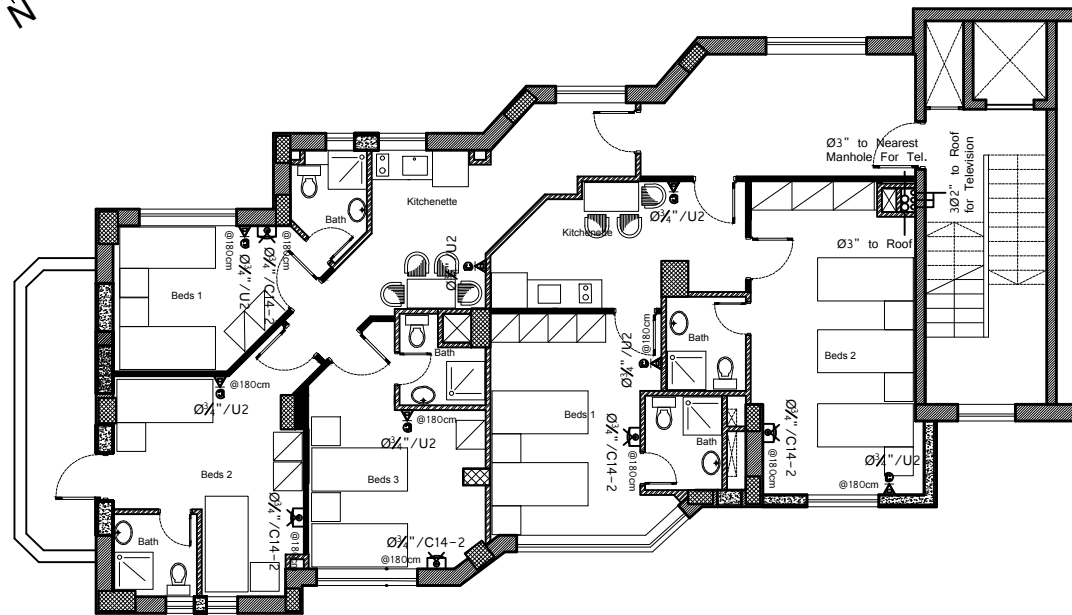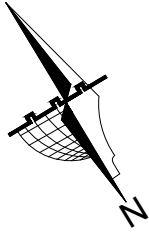

REVISION A :

Name: \_\_\_\_\_

Date : \_\_\_\_\_

Remarks: \_\_\_\_\_

\_\_\_\_\_

\_\_\_\_\_

\_\_\_\_\_

\_\_\_\_\_

\_\_\_\_\_

\_\_\_\_\_

REVISION B :

Name: \_\_\_\_\_

Date : \_\_\_\_\_

Remarks: \_\_\_\_\_

\_\_\_\_\_

\_\_\_\_\_

\_\_\_\_\_

\_\_\_\_\_

\_\_\_\_\_

\_\_\_\_\_



المسجل للخدمة  
الالكتروميكانيكية  
رام الله - شارع محطة الصنع  
عمارة الميراني - الطريق الرابع  
تلفون ٣٣٧٧٣٧٣

DESIGNED BY : Amant An-Nasser  
CHECKED BY : Pinus Geth  
DRAWN BY : Amant An-Nasser



FJPU

TITLE:  
Fourth Floor  
Low Voltage  
Systems

OWNER :

Drawing No. E26

SCALE DATE  
1:100 26/11/2015

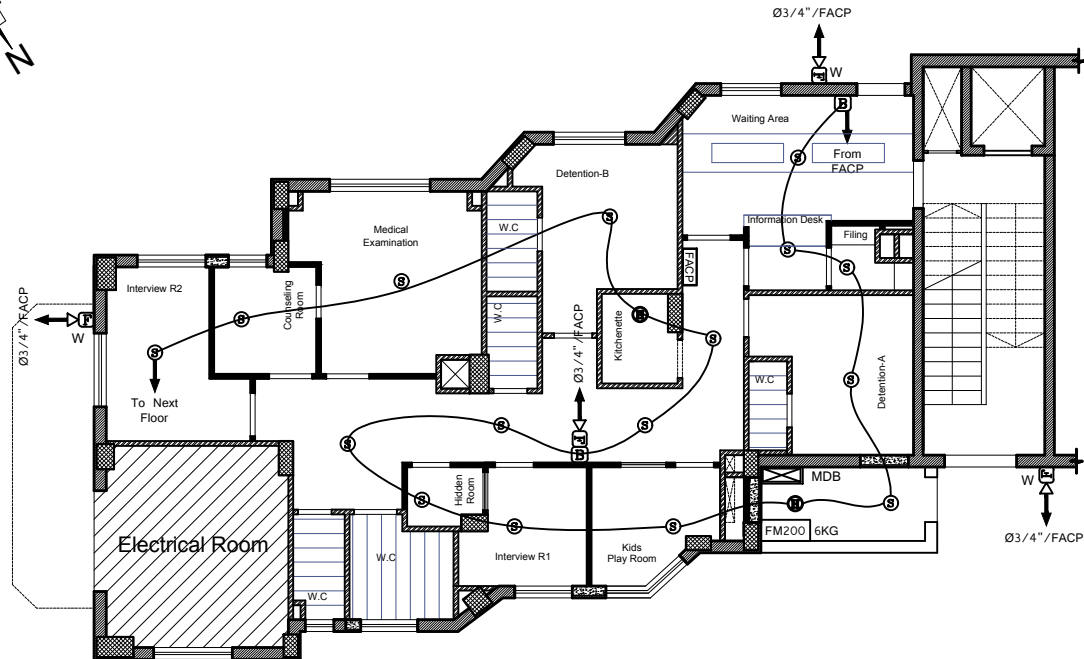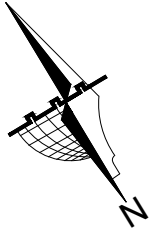

REVISION A :

Name: \_\_\_\_\_

Date : \_\_\_\_\_

Remarks: \_\_\_\_\_

\_\_\_\_\_

\_\_\_\_\_

\_\_\_\_\_

\_\_\_\_\_

\_\_\_\_\_

\_\_\_\_\_

REVISION B :

Name: \_\_\_\_\_

Date : \_\_\_\_\_

Remarks: \_\_\_\_\_

\_\_\_\_\_

\_\_\_\_\_

\_\_\_\_\_

\_\_\_\_\_

\_\_\_\_\_

\_\_\_\_\_



المملكة العربية  
السعودية  
السلطة العامة  
للحماية المدنية  
رام الله - شارع محطة الصالح  
عمارة الميناء - الطابق الرابع  
تلفون ٩٠١١١١١١١

DESIGNED BY : Amant An-Nasser  
CHECKED BY : Pinar Geli  
DRAWN BY : Amant An-Nasser



FJPU

TITLE:  
Ground Floor  
Fire Alarm System

OWNER :

Drawing No. E27

SCALE DATE  
1:100 26/11/2015

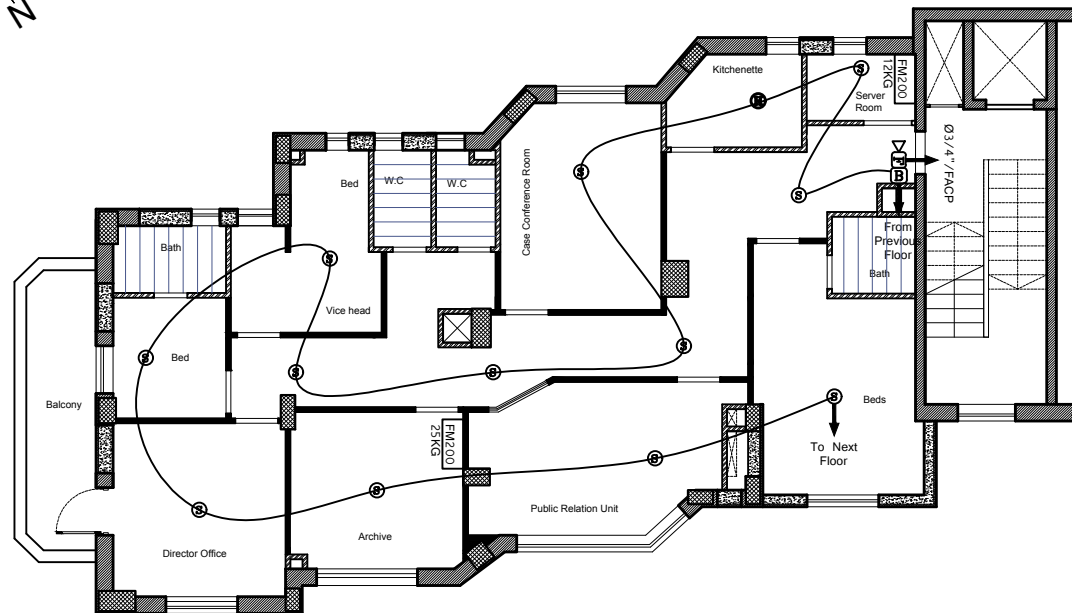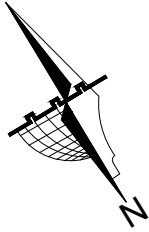

REVISION A :

Name: \_\_\_\_\_

Date : \_\_\_\_\_

Remarks: \_\_\_\_\_

\_\_\_\_\_

\_\_\_\_\_

\_\_\_\_\_

\_\_\_\_\_

\_\_\_\_\_

REVISION B :

Name: \_\_\_\_\_

Date : \_\_\_\_\_

Remarks: \_\_\_\_\_

\_\_\_\_\_

\_\_\_\_\_

\_\_\_\_\_

\_\_\_\_\_

\_\_\_\_\_



المسجل للخدمة  
الإلكترونيكا نيكية  
رام الله - شارع محطة الصلح  
عمارة المهندس - الطابق الرابع  
تلفاس ٠١١١١١١١١

DESIGNED BY : Amant An-Nasser  
CHECKED BY : Pinar Geli  
DRAWN BY : Amant An-Nasser


FJPU

TITLE:  
First Floor  
Fire Alarm System

OWNER :


Drawing No. E28

SCALE DATE  
1:100 26/11/2015

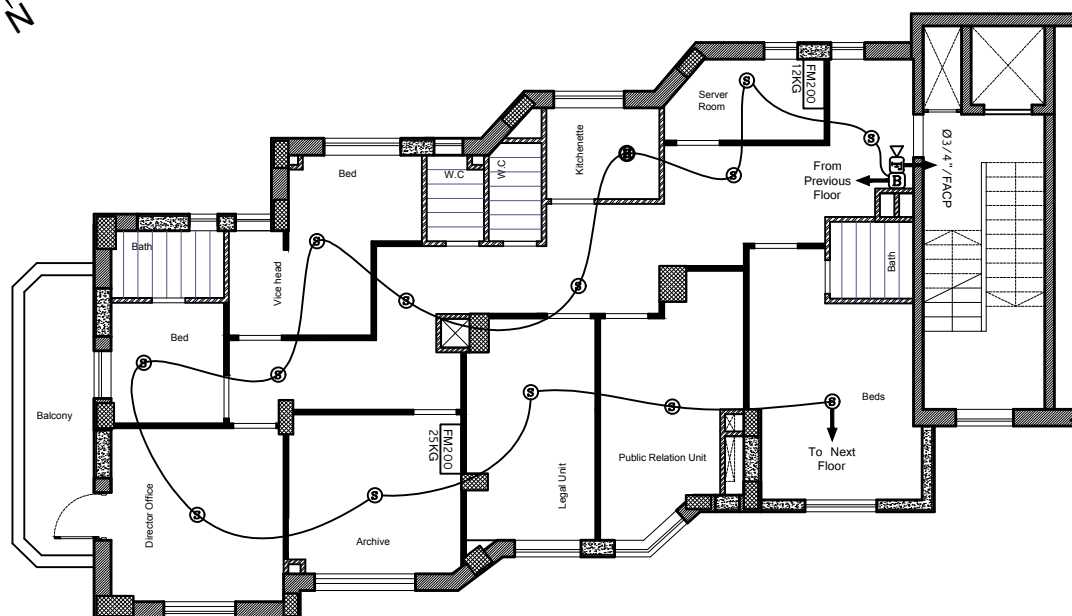

|  |  |
|--|--|
|  |  |
|--|--|


|  |  |
|--|--|
|  |  |
|--|--|

 

FJPU


OWNER :

|       |            |
|-------|------------|
| SCALE | DATE       |
| 1:100 | 26/11/2015 |

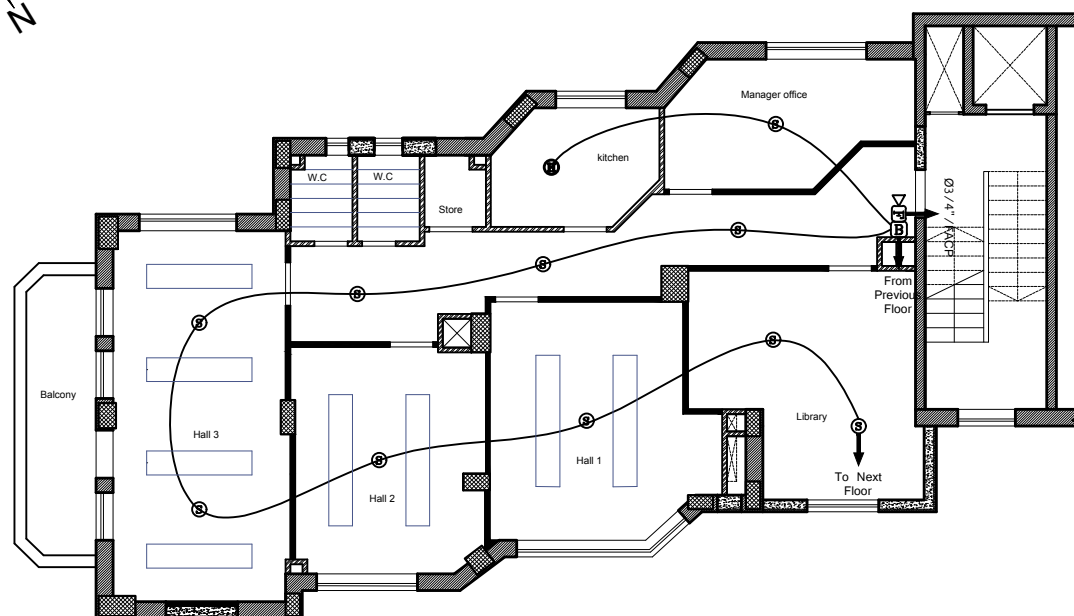

|  |  |
|--|--|
|  |  |
|--|--|


 
---



**DRAWN BY :** Amani An-Nasser

### Third Floor Fire Alarm System

|       |            |
|-------|------------|
| SCALE | DATE       |
| 1:100 | 26/11/2015 |

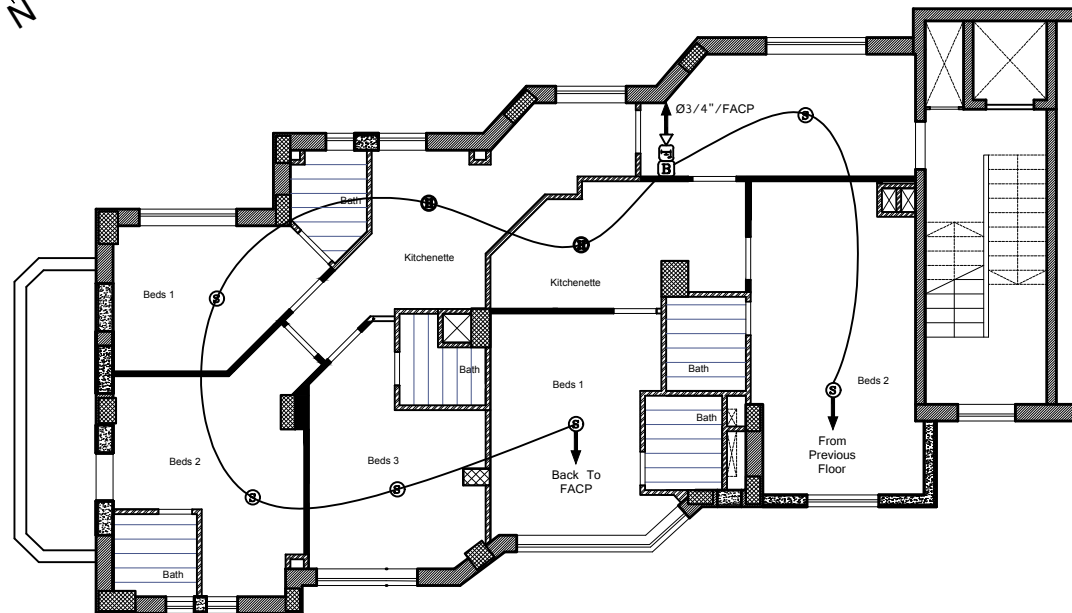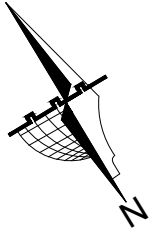

REVISION A :

Name: \_\_\_\_\_

Date : \_\_\_\_\_

Remarks: \_\_\_\_\_

\_\_\_\_\_

\_\_\_\_\_

\_\_\_\_\_

\_\_\_\_\_

\_\_\_\_\_

REVISION B :

Name: \_\_\_\_\_

Date : \_\_\_\_\_

Remarks: \_\_\_\_\_

\_\_\_\_\_

\_\_\_\_\_

\_\_\_\_\_

\_\_\_\_\_

\_\_\_\_\_



المشغل للخدمة  
الإلكترونيكا نيكية  
رام الله - شارع محطة الصلح  
عمارة المينوي - الطابق الرابع  
تلفون ٩٠٧٧٧٧٧

DESIGNED BY : Amant An-Nasser  
CHECKED BY : Pirus Geth  
DRAWN BY : Amant An-Nasser



FJPU

TITLE:  
Fourth Floor  
Fire Alarm System

OWNER :

Drawing No. E31

SCALE 1:100 DATE 26/11/2015

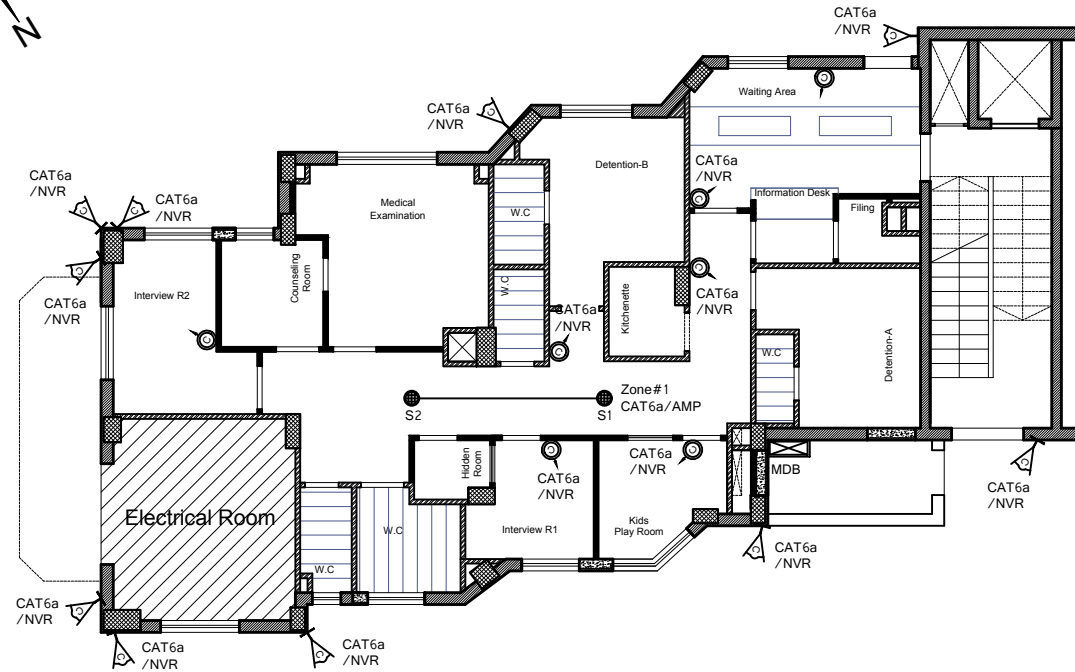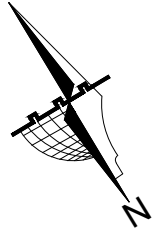

REVISION A :

Name: \_\_\_\_\_

Date : \_\_\_\_\_

Remarks: \_\_\_\_\_

\_\_\_\_\_

\_\_\_\_\_

\_\_\_\_\_

\_\_\_\_\_

\_\_\_\_\_

REVISION B :

Name: \_\_\_\_\_

Date : \_\_\_\_\_

Remarks: \_\_\_\_\_

\_\_\_\_\_

\_\_\_\_\_

\_\_\_\_\_

\_\_\_\_\_

\_\_\_\_\_



القسم للخدمة  
الإلكترونية  
رام الله - شارع محطة الصلح  
عمارة الميناء - الطابق الرابع  
تلفون ٩٠٧٧٧٧٧

DESIGNED BY : Amant An-Nasser  
CHECKED BY : Pinar Geli  
DRAWN BY : Amant An-Nasser



*FJPU*

TITLE:  
Ground Floor  
CCTV & Sound  
Systems

OWNER :

Drawing No. E32

SCALE DATE  
1:100 26/11/2015

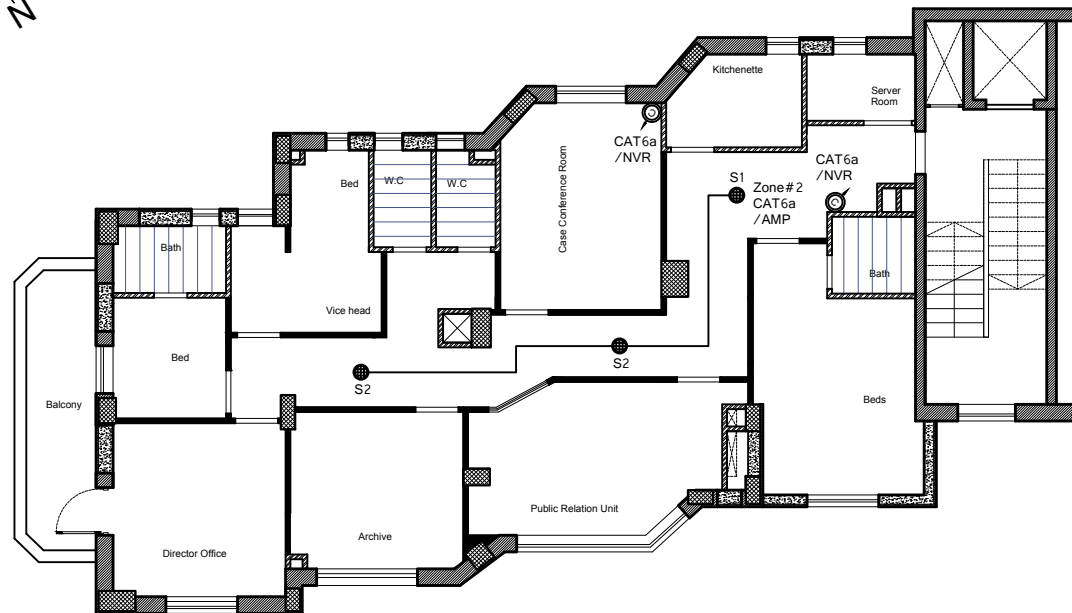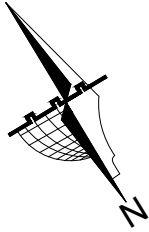

REVISION A :

Name: \_\_\_\_\_

Date : \_\_\_\_\_

Remarks: \_\_\_\_\_

\_\_\_\_\_

\_\_\_\_\_

\_\_\_\_\_

\_\_\_\_\_

\_\_\_\_\_

\_\_\_\_\_

REVISION B :

Name: \_\_\_\_\_

Date : \_\_\_\_\_

Remarks: \_\_\_\_\_

\_\_\_\_\_

\_\_\_\_\_

\_\_\_\_\_

\_\_\_\_\_

\_\_\_\_\_

\_\_\_\_\_



القسم للخدمة  
الإلكترونية  
رام الله - شارع جامعة الملك  
عمارة المهندس - الطابق الرابع  
تلفون ٩٠٧٧٧٧٧

DESIGNED BY : Amant An-Nasser  
CHECKED BY : Pius Geth  
DRAWN BY : Amant An-Nasser



FJPU

TITLE:  
First Floor  
CCTV & Sound  
Systems

OWNER :

Drawing No. E33

SCALE DATE  
1:100 26/11/2015

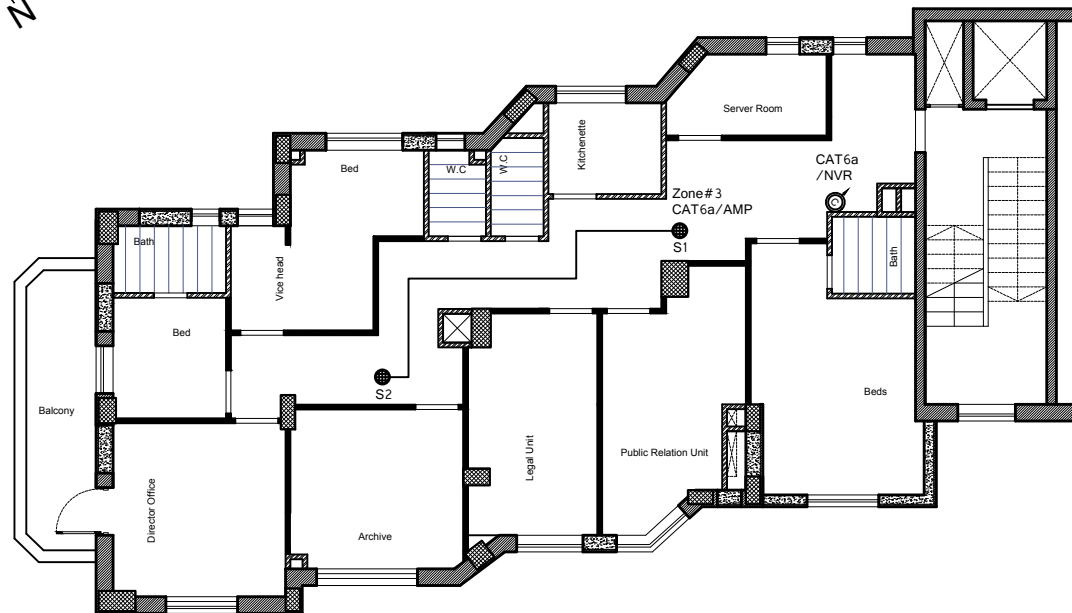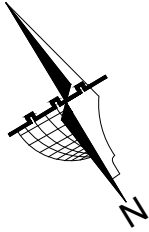

REVISION A :

Name: \_\_\_\_\_

Date : \_\_\_\_\_

Remarks: \_\_\_\_\_

\_\_\_\_\_

\_\_\_\_\_

\_\_\_\_\_

\_\_\_\_\_

\_\_\_\_\_

\_\_\_\_\_

REVISION B :

Name: \_\_\_\_\_

Date : \_\_\_\_\_

Remarks: \_\_\_\_\_

\_\_\_\_\_

\_\_\_\_\_

\_\_\_\_\_

\_\_\_\_\_

\_\_\_\_\_

\_\_\_\_\_



القطاع للخدمة  
الالكتروميكانيكية  
رام الله - شارع جامعة الملك  
عمارة المهندس - الطابق الرابع  
تلفون ٩٠٧٧٧٧٧

DESIGNED BY : Amant An-Nasser  
CHECKED BY : Pius Geth  
DRAWN BY : Amant An-Nasser



FJPU

TITLE:  
Second Floor  
CCTV & Sound  
Systems

OWNER :

Drawing No. E34

SCALE 1:100 DATE 26/11/2015

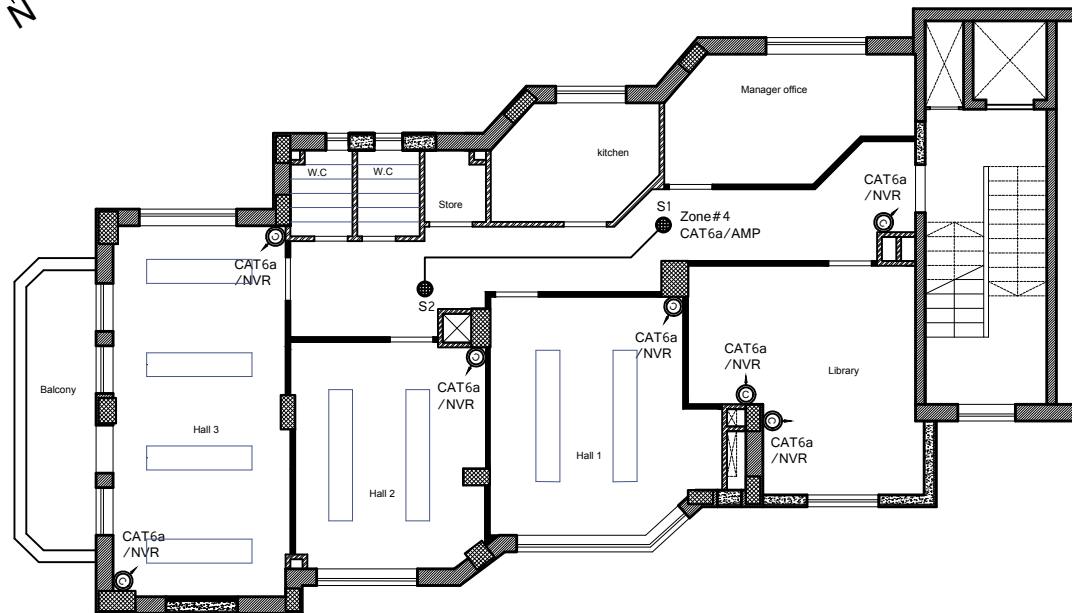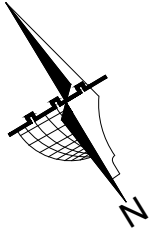

REVISION A :

Name: \_\_\_\_\_

Date : \_\_\_\_\_

Remarks: \_\_\_\_\_

\_\_\_\_\_

\_\_\_\_\_

\_\_\_\_\_

\_\_\_\_\_

\_\_\_\_\_

\_\_\_\_\_

REVISION B :

Name: \_\_\_\_\_

Date : \_\_\_\_\_

Remarks: \_\_\_\_\_

\_\_\_\_\_

\_\_\_\_\_

\_\_\_\_\_

\_\_\_\_\_

\_\_\_\_\_

\_\_\_\_\_



المستشار للخدمة  
الإلكترونية  
رام الله - شارع محطة الصلح  
عمارة الميناء - الطابق الرابع  
تلفون ٣٣٧٧٧٧٧

DESIGNED BY : Amant An-Nasser  
CHECKED BY : Pinus Geth  
DRAWN BY : Amant An-Nasser



FJPU

TITLE:  
Third Floor  
CCTV & Sound  
Systems

OWNER :

Drawing No. E35

SCALE 1:100 DATE 26/11/2015

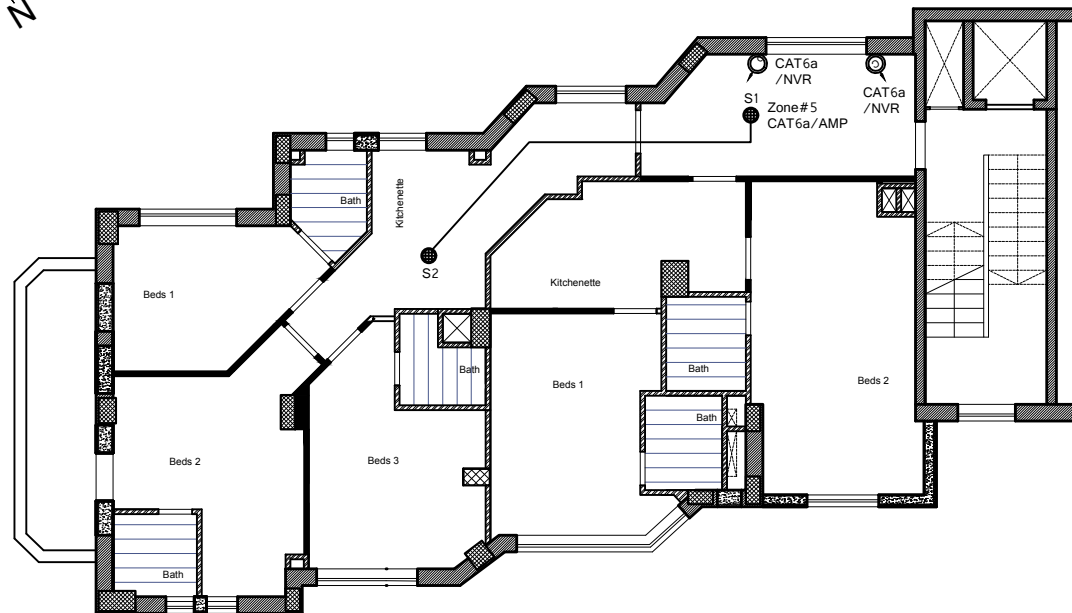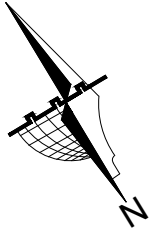

REVISION A :

Name: \_\_\_\_\_

Date : \_\_\_\_\_

Remarks: \_\_\_\_\_

\_\_\_\_\_

\_\_\_\_\_

\_\_\_\_\_

\_\_\_\_\_

\_\_\_\_\_

REVISION B :

Name: \_\_\_\_\_

Date : \_\_\_\_\_

Remarks: \_\_\_\_\_

\_\_\_\_\_

\_\_\_\_\_

\_\_\_\_\_

\_\_\_\_\_

\_\_\_\_\_



المشغل للخدمة  
الالكتروميكانيكية  
رام الله - شارع جامعة الملك  
عبدالله - الطابق الرابع  
تلفون ٩٠٧٧٧٧٧

DESIGNED BY : Amant An-Nasser  
CHECKED BY : Pirus Geth  
DRAWN BY : Amant An-Nasser


FJPU

TITLE:  
Fourth Floor  
CCTV & Sound  
Systems

OWNER :

Drawing No. E36

SCALE 1:100 DATE 26/11/2015

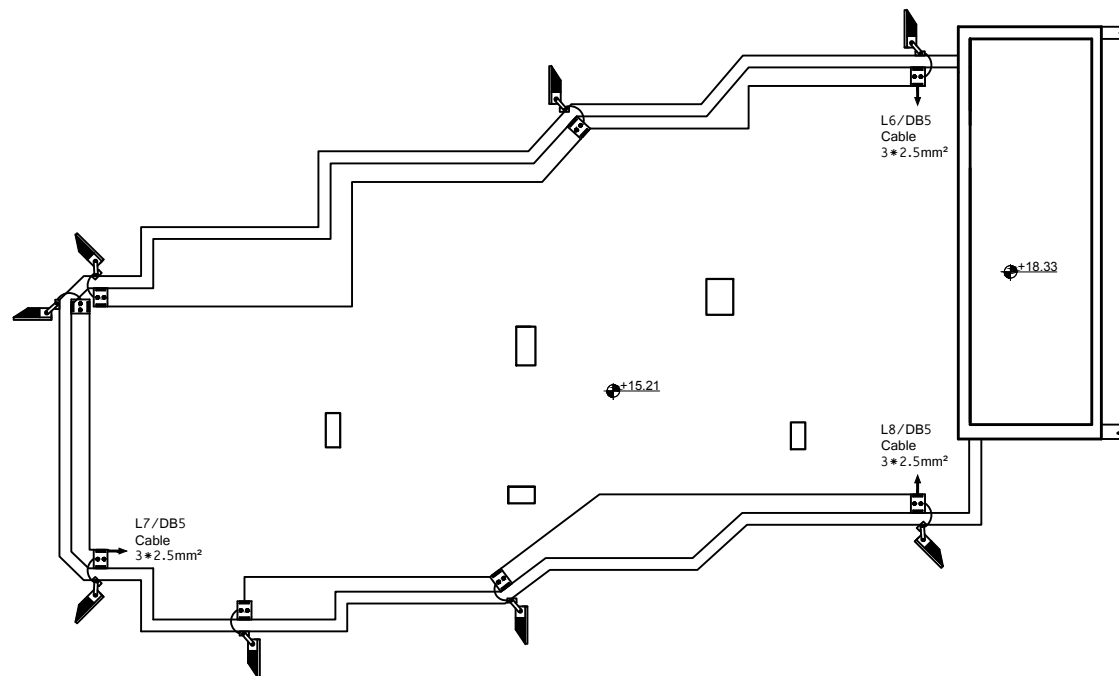

REVISION A :

Name: \_\_\_\_\_

Date : \_\_\_\_\_

Remarks: \_\_\_\_\_

\_\_\_\_\_

\_\_\_\_\_

\_\_\_\_\_

\_\_\_\_\_

\_\_\_\_\_

REVISION B :

Name: \_\_\_\_\_

Date : \_\_\_\_\_

Remarks: \_\_\_\_\_

\_\_\_\_\_

\_\_\_\_\_

\_\_\_\_\_

\_\_\_\_\_

\_\_\_\_\_



القسم الهندسة  
الكهربائية  
رام الله - شارع محطة الصلح  
عمارة الجيتني - الطابق الرابع  
تلفا ٩٧٧٧٧٧٧

DESIGNED BY : Amant An-Nasser  
CHECKED BY : Pinus Geth  
DRAWN BY : Amant An-Nasser



FJPU

TITLE:  
Flood Lights on  
the Roof

OWNER :

Drawing No. E37

SCALE 1:100 DATE 26/11/2015

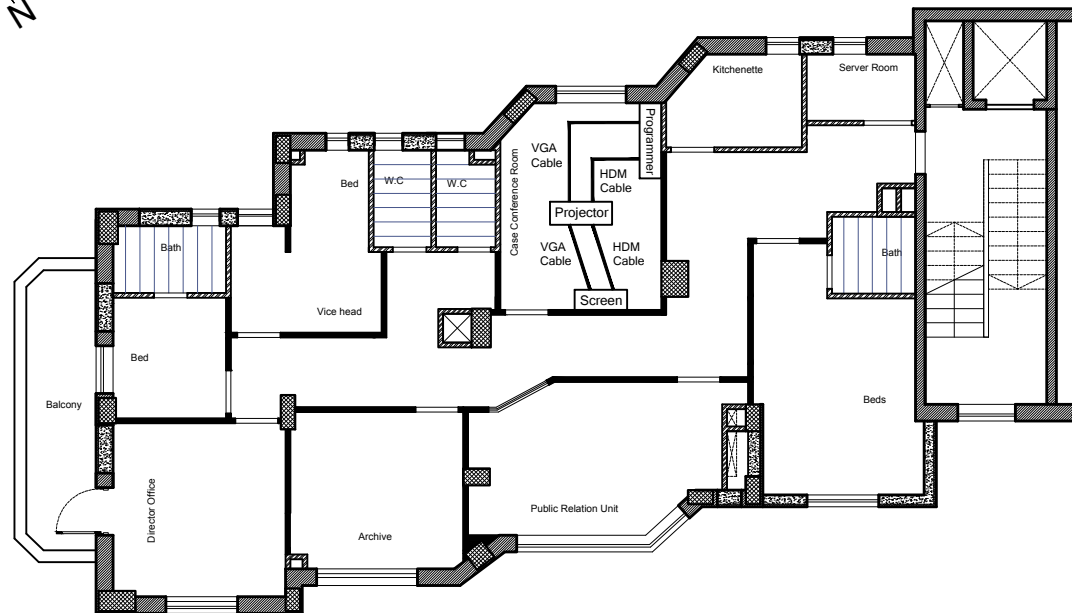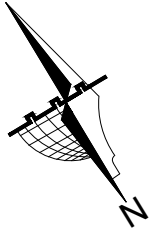

REVISION A :

Name: \_\_\_\_\_

Date : \_\_\_\_\_

Remarks: \_\_\_\_\_

\_\_\_\_\_

\_\_\_\_\_

\_\_\_\_\_

\_\_\_\_\_

\_\_\_\_\_

\_\_\_\_\_

REVISION B :

Name: \_\_\_\_\_

Date : \_\_\_\_\_

Remarks: \_\_\_\_\_

\_\_\_\_\_

\_\_\_\_\_

\_\_\_\_\_

\_\_\_\_\_

\_\_\_\_\_

\_\_\_\_\_



القسم للخدمة  
الإلكترونية  
رام الله - شارع جامعة الملك  
عصاة الميراثي - الطابق الرابع  
تلفون ٠١١١١١١١١

DESIGNED BY : Amant An-Nasser  
CHECKED BY : Pius Geth  
DRAWN BY : Amant An-Nasser



FJPU

TITLE:  
Meeting Room  
Projector Details

OWNER :

Drawing No. E38

SCALE DATE  
1:100 26/11/2015

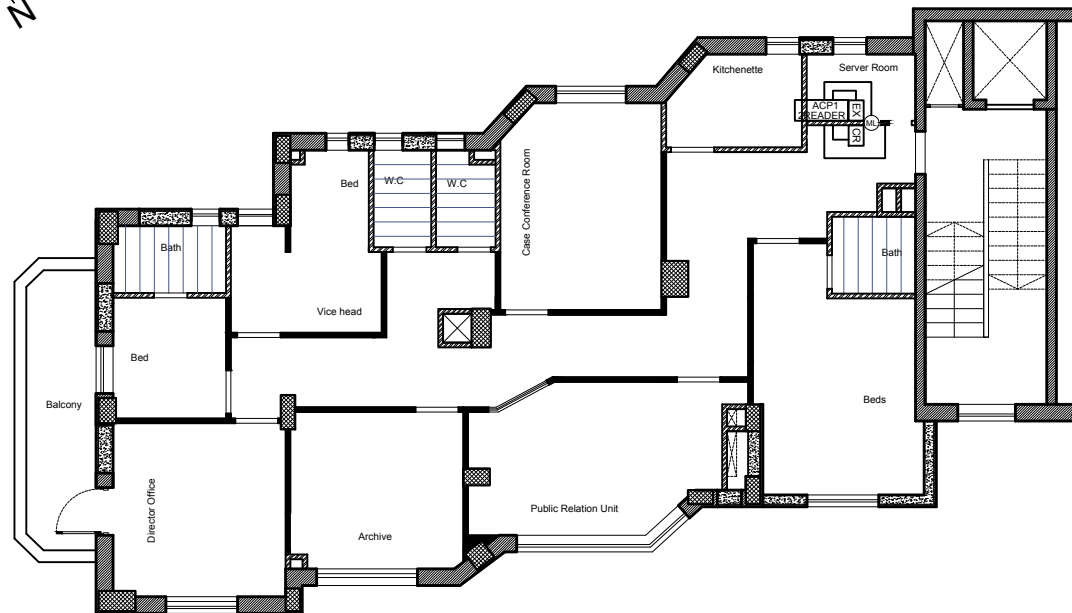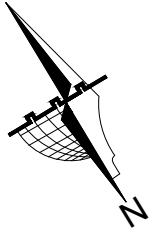

REVISION A :

Name: \_\_\_\_\_

Date : \_\_\_\_\_

Remarks: \_\_\_\_\_

\_\_\_\_\_

\_\_\_\_\_

\_\_\_\_\_

\_\_\_\_\_

\_\_\_\_\_

\_\_\_\_\_

REVISION B :

Name: \_\_\_\_\_

Date : \_\_\_\_\_

Remarks: \_\_\_\_\_

\_\_\_\_\_

\_\_\_\_\_

\_\_\_\_\_

\_\_\_\_\_

\_\_\_\_\_

\_\_\_\_\_



القسم للخدمة  
الإلكترونية  
رام الله - شارع جامعة الملك  
عصارة المينتي - الطابق الرابع  
تلفون ٠١١١١١١١١١١

DESIGNED BY : Amant An-Nasser  
CHECKED BY : Pinar Geli  
DRAWN BY : Amant An-Nasser



FJPU

TITLE:  
Server Room  
Access Control  
System - 1

OWNER :

Drawing No. E39

SCALE DATE  
1:100 26/11/2015

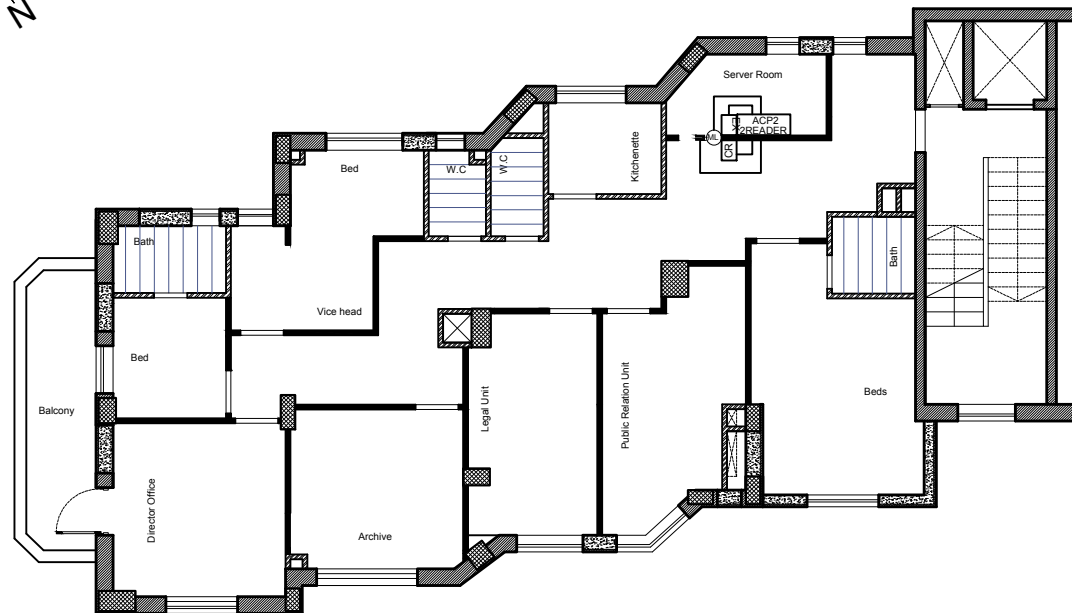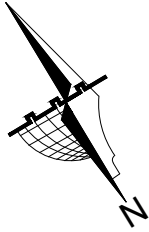

REVISION A :

Name: \_\_\_\_\_

Date : \_\_\_\_\_

Remarks: \_\_\_\_\_

\_\_\_\_\_

\_\_\_\_\_

\_\_\_\_\_

\_\_\_\_\_

\_\_\_\_\_

\_\_\_\_\_

REVISION B :

Name: \_\_\_\_\_

Date : \_\_\_\_\_

Remarks: \_\_\_\_\_

\_\_\_\_\_

\_\_\_\_\_

\_\_\_\_\_

\_\_\_\_\_

\_\_\_\_\_

\_\_\_\_\_



القسم للخدمة  
الإلكترونية  
رام الله - شارع جامعة الملك  
عصارة المينتي - الطابق الرابع  
تلفون ٠١١١١١١١١

DESIGNED BY : Amant An-Nasser  
CHECKED BY : Pirus Geth  
DRAWN BY : Amant An-Nasser


FJPU

TITLE:  
Server Room  
Access Control  
System - 2

OWNER :

Drawing No. E40

SCALE 1:100 DATE 26/11/2015

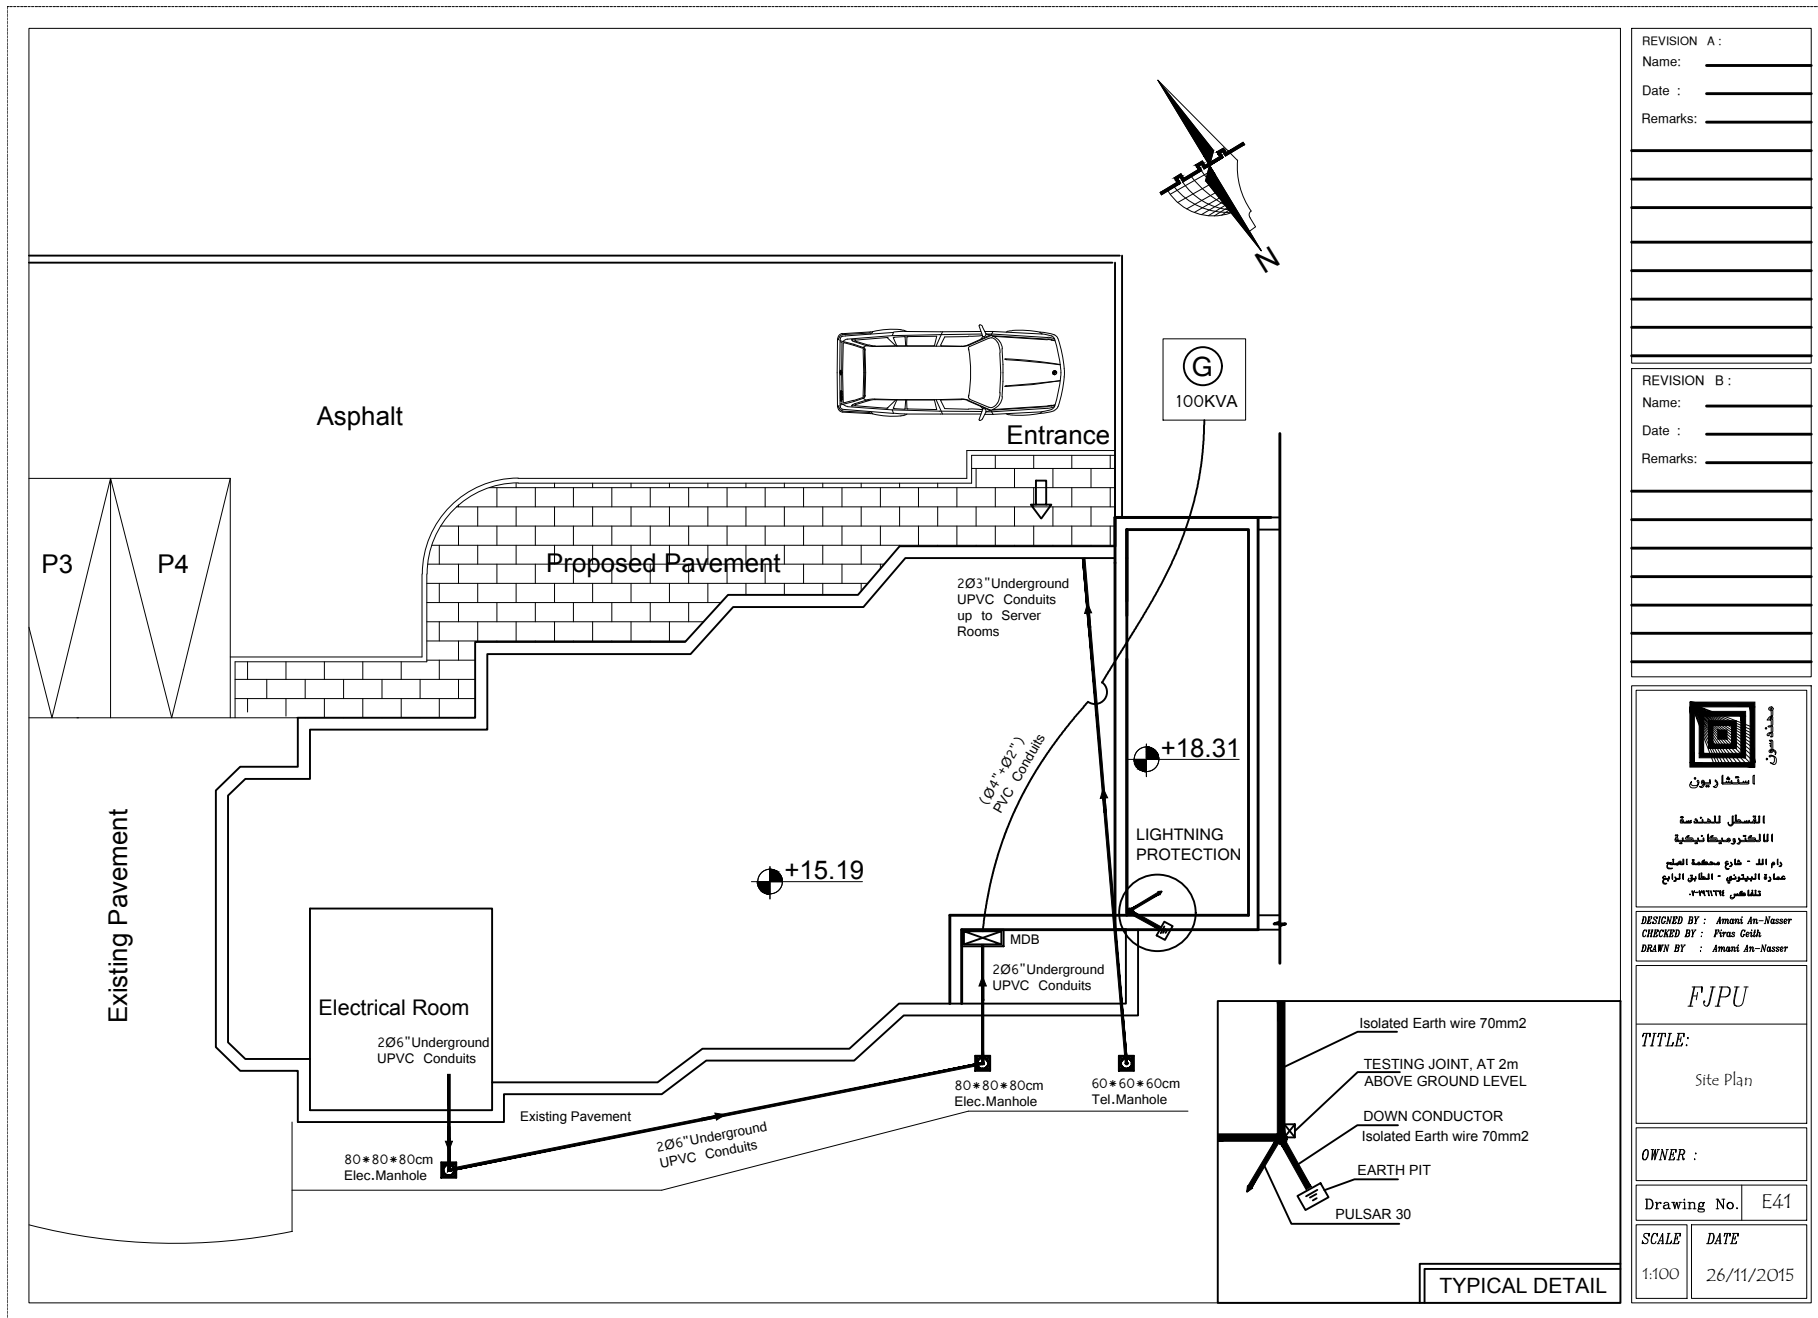

REVISION A :

Name: \_\_\_\_\_

Date : \_\_\_\_\_

Remarks: \_\_\_\_\_

REVISION B :

Name: \_\_\_\_\_

Date : \_\_\_\_\_

Remarks: \_\_\_\_\_



المملكة العربية السعودية  
السلطة العامة للكهرباء والمياه  
رام الله - شارع محطة الصالح  
عمارة المهندس - الطابق الرابع  
تلفون ٥٠٠٠٠٠٠٠

DESIGNED BY : Amant An-Nasser  
CHECKED BY : Pius Gith  
DRAWN BY : Amant An-Nasser



FJPU

TITLE:  
Site Plan

OWNER :

Drawing No. E41

SCALE 1:100 DATE 26/11/2015

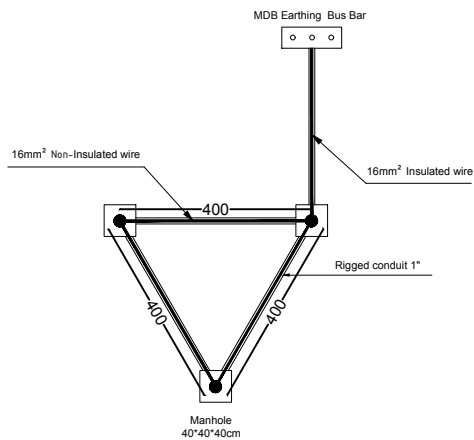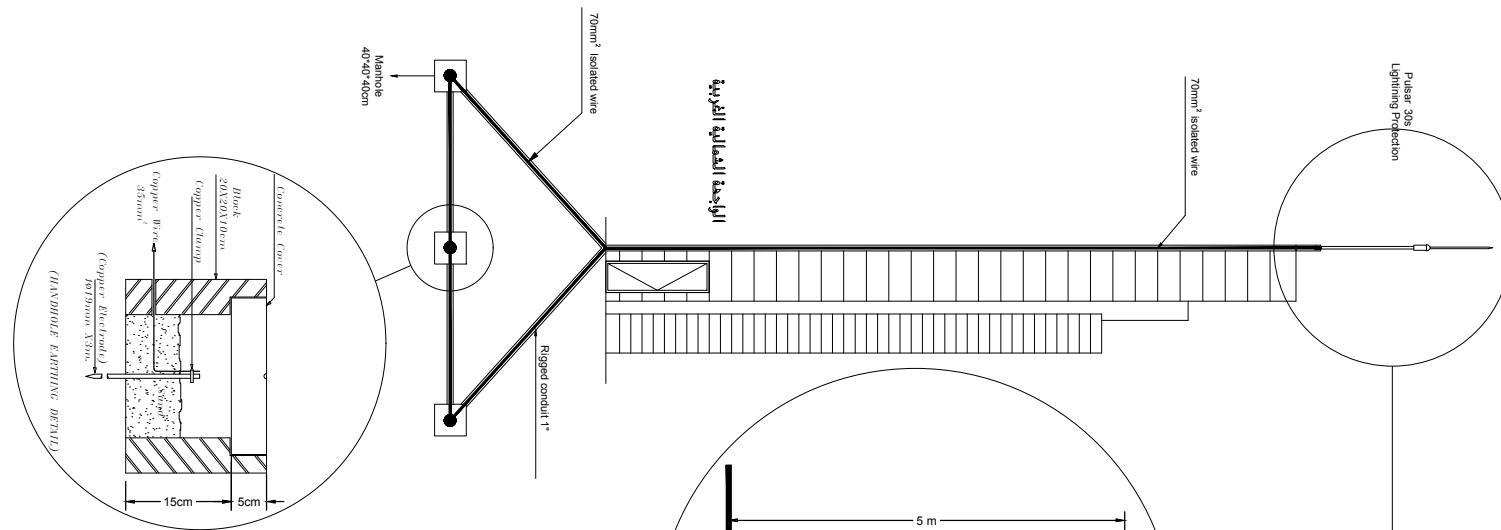

Earthing System Details

Lightning System Details

REVISION A :

Name: \_\_\_\_\_

Date : \_\_\_\_\_

Remarks: \_\_\_\_\_

REVISION B :

Name: \_\_\_\_\_

Date : \_\_\_\_\_

Remarks: \_\_\_\_\_



السلطنة  
إستشاريون

المشغل للخدمة  
الالكتروميكانيكية

رام الله - شارع محطة الصلح  
عمارة المينتي - الطابق الرابع  
تلفاكس ٠٩٣٧٧٣٦٦

DESIGNED BY : Amant An-Nasser  
CHECKED BY : Pinar Geli  
DRAWN BY : Amant An-Nasser

FJPU




TITLE:  
Lightning System  
Details

OWNER :

Drawing No. E42

SCALE DATE  
1:100 26/11/2015



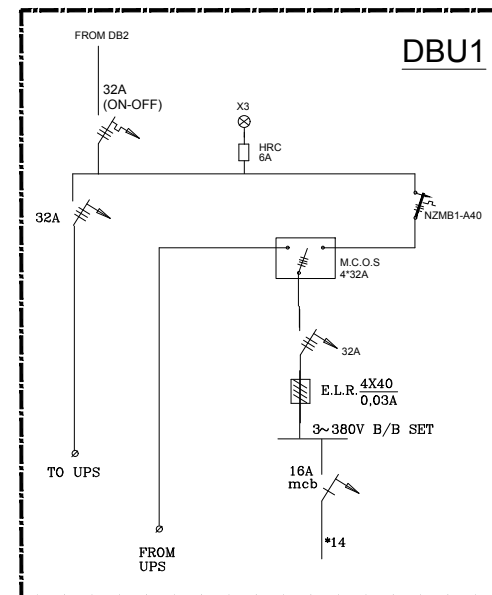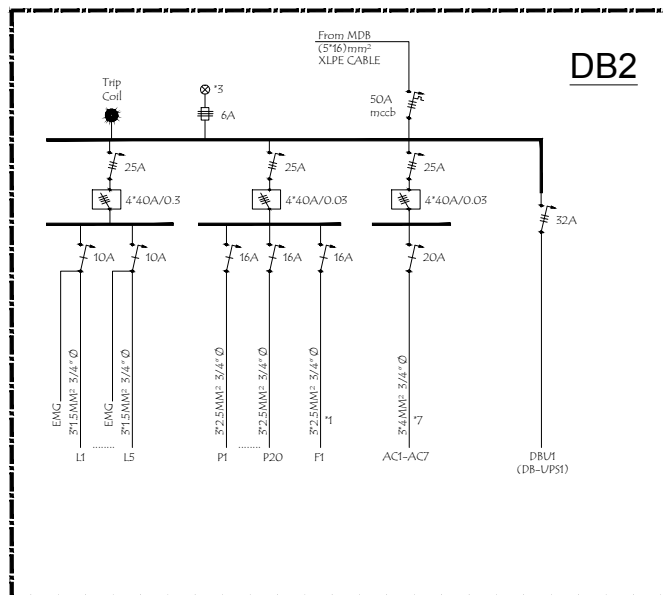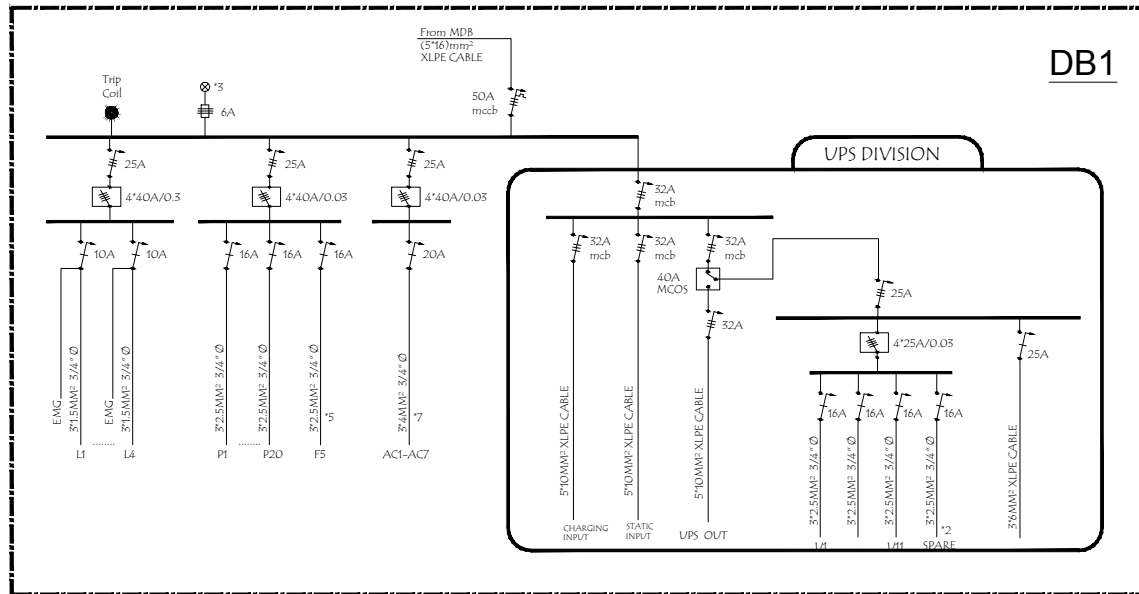

REVISION A :

Name: \_\_\_\_\_

Date : \_\_\_\_\_

Remarks: \_\_\_\_\_

REVISION B :

Name: \_\_\_\_\_

Date : \_\_\_\_\_

Remarks: \_\_\_\_\_



استشاريون

المسجل للخدمة  
الالكترونيكا نيكية

رام الله - شارع محطة الصلح  
عمارة المينوتشي - الطريق الرابع  
تلفاخي ٩٣٧٧٧٦

DESIGNED BY : Amant An-Nasser  
CHECKED BY : Pinar Geli  
DRAWN BY : Amant An-Nasser



FJPU

TITLE:  
Electrical Distribution  
Boards 2

OWNER :

Drawing No. E44

SCALE DATE  
1:100 26/11/2015

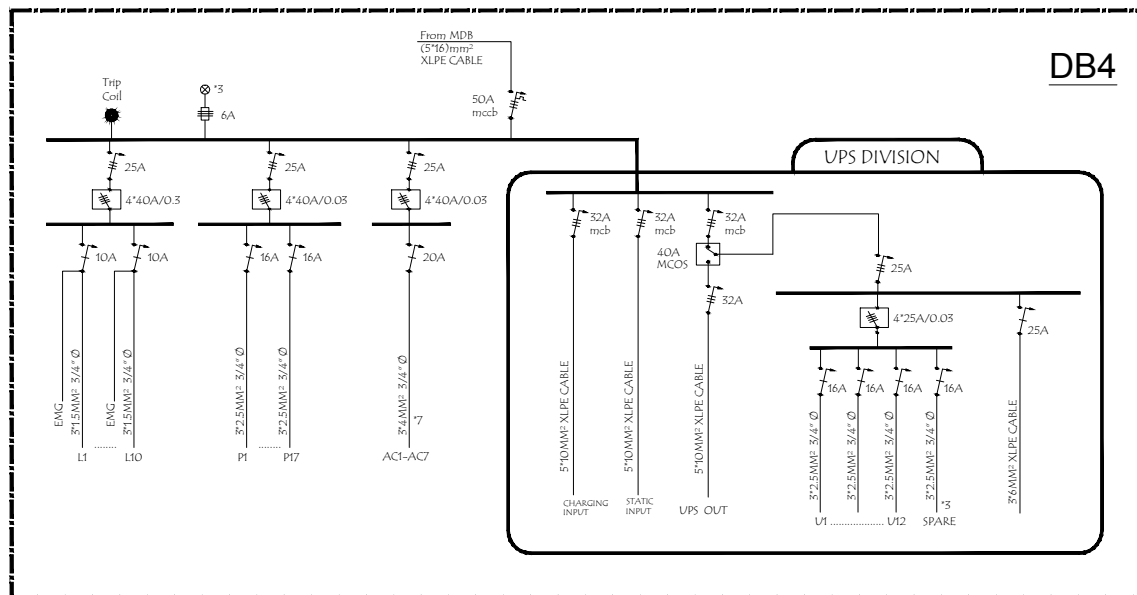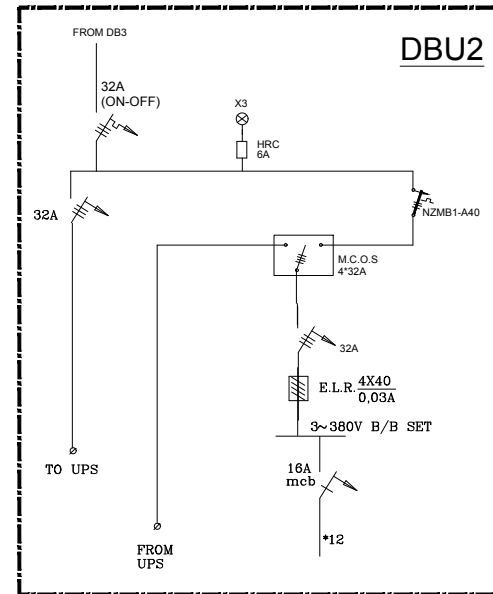[illegible]

القسطل للهندسة  
الالكتروميكانيكية  
رام الله - شارع محطة الصالح  
صعادة البيتوني - الطابق الرابع  
تلفاخن ٠٥-٣٦٦٦٦٦

DESIGNED BY : Amani An-Nasser  
CHECKED BY : Firas Geith  
DRAWN BY : Amani An-Nasser

FJPU

**TITLE:**  
Electrical Distribution  
Boards 3

OWNER :

|             |     |
|-------------|-----|
| Drawing No. | E45 |
|-------------|-----|

|              |             |
|--------------|-------------|
| <i>SCALE</i> | <i>DATE</i> |
| 1:100        | 26/11/2015  |

