



State of Palestine
Ministry of Education & Higher Education

NOTES :-

AL shejaia BUILDING		LIST OF DRAWINGS							
A	ARCHITECTURAL DRAWINGS	S	STRUCTURAL DRAWINGS	E	ELECTRICAL DRAWINGS	M	MECHANICAL DRAWINGS	D	DESALINATION DRAWINGS
SHEET NO.		SHEET TITLE							
GENERAL									
000	LIST OF DRAWINGS	001	COLUMN AXIS	001	ELECTRIC WORKS LEGEND	MS0	SEWAGE SYSTEM FOR SITE PLAN		
001	EXISTING TOPOGRAPHY SITE PLAN	002	FOUNDATIONS DETAILS	002	ELECTRICAL SITE LAYOUT	MW0	WATER DISTRIBUTION SYSTEM FOR SITE PLAN		
002	SITE PLAN LAYOUT	003	DETAILS OF COLUMNS & FOUNDATION	003	EARTHING SYSTEM LAYOUT	MF0	FIRE FIGHTING SYSTEM FOR SITE PLAN		
003	GROUND FLOOR AREAS	004	DETAILS OF COLUMNS & GROUND BEAMS	004	GROUND FLOOR LIGHTING SYSTEM LAYOUT	001	SEWAGE SYSTEM FOR GROUND FLOOR		
004	FIRST FLOOR AREAS	005	GROUND BEAMS	005	GROUND FLOOR POWER SYSTEM LAYOUT	002	SEWAGE SYSTEM FOR FIRST FLOOR		
005	SECOND FLOOR AREAS	006	GROUND FLOOR SLAB	006	GROUND FLOOR AUDIO & DATA SYSTEM LAYOUT	003	SEWAGE SYSTEM FOR SECOND FLOOR		
006	THIRD FLOOR AREAS	007	FIRST FLOOR SLAB	007	FIRST FLOOR LIGHTING SYSTEM LAYOUT	004	SEWAGE SYSTEM FOR ROOF FLOOR		
PLANS		008	SECOND FLOOR SLAB	008	FIRST FLOOR POWER SYSTEM LAYOUT	005	ROOF DRAINAGE PLAN		
007	GROUND FLOOR PLAN	009	BEAMS SLABS DETAILS -1-	009	SECOND FLOOR LIGHTING SYSTEM LAYOUT	006	WATER DISTRIBUTION SYSTEM FOR GROUND FLOOR		
008	FIRST FLOOR PLAN	010	BEAMS SLABS DETAILS -2-	010	SECOND FLOOR POWER SYSTEM LAYOUT	007	WATER DISTRIBUTION SYSTEM FOR FIRST FLOOR		
009	SECOND FLOOR PLAN	011	STAIR CASE DETAILS	011	EXTERNAL LIGHTING	008	WATER DISTRIBUTION SYSTEM FOR SECOND FLOOR		
010	THIRD FLOOR PLAN	012	SPORT FIELD DETAILS & MPH DETAILS	012	COM. LAPORATORY DETAILS	009	WATER DISTRIBUTION SYSTEM FOR ROOF FLOOR		
011	ROOF PLAN			013	WATER CONTROL PANEL	010	FIRE FIGHTING SYSTEM FOR GROUND FLOOR		
012	TOP ROOF PLAN			014	PV SYSTEM ROOF PLAN ELECTRIC WORKS	011	FIRE FIGHTING SYSTEM FOR FIRST FLOOR		
ELEVATIONS & SECTIONS				015	WEIGHTS OF PV SOLAR SYSTEM EQUIPMENTS	012	FIRE FIGHTING SYSTEM FOR SECOND FLOOR		
013	FIRST ELEVATION			016	WEIGHTS OF BATTERIES ELECTRIC WORKS	013	FIRE FIGHTING SYSTEM FOR ROOF FLOOR		
014	SECOND ELEVATION			017	SUB-MAIN DISTRIBUTION BOARDS -1-	014	FIRE FIGHTING SYSTEM AT THE TOP ROOF		
015	THIRD ELEVATION			018	SUB-MAIN DISTRIBUTION BOARDS -2-	015	GAS SYSTEM FOR SCIENCE LAB. PLAN.		
016	FOURTH ELEVATION			019	SUB-DISTRIBUTION BOARDS -1-	016	VENTILATION SYSTEM FOR MULTI AERAS PLAN		
017	SECTION A-A			020	SUB-DISTRIBUTION BOARDS -2-	017	VENTILATION SYSTEM MP HALL PLAN		
018	SECTION B-B			021	SUB-DISTRIBUTION BOARDS -3-	MD1	DETAIL-1		
TYPICAL DETAILS				022	SUB-DISTRIBUTION BOARDS -4-				
019	DOORS SCHEDULE			023	MDB WITH PHOTO-VOLTAIC ENERGY SYSTEM SINGLE LINE DIAGRAM				
020	WINDOWS SCHEDULE								
021	FINISHING SCHEDULE								
022	STAIRS DETAILS								
023	MULTI PURPOSE HALL DETAILS - GROUND FLOOR PLAN -								
024	MULTI PURPOSE HALL DETAILS - UPPER PLAN -								
025	MULTI PURPOSE HALL DETAILS - TOP VIEW HALL -								
026	MULTI PURPOSE HALL DETAILS - SECTION A-A -								
027	MULTI PURPOSE HALL DETAILS - ELEVATION 1+2 -								
028	MULTI PURPOSE HALL DETAILS - ELEVATION 3+4 -								
029	MULTI PURPOSE HALL DETAILS - TOILETS DETAILS -								
030	SCIENCE LAB DETAILS -1-								
031	SCIENCE LAB DETAILS -2-								
032	CLASSROOM DETAILS								
033	CATEEN DETAILS								
034	PROPOSED PLAYGROUND DETAILS								
035	GENERAL DETAIL -1-								
036	GENERAL DETAIL -2-								
037	GENERAL DETAIL -3-								
038	GENERATOR ROOM DETAIL -3-								

FUNDED BY:



EMPLEMENTED BY:



Empowered lives, Resilient nation

IN COOPERATION WITH:



CONSULTANT:



ABUSHAHLA & ASSOCIATES
"Consulting Engineers"
Palestine

+970-8-2864067 / +970-8-2828971

Eshjaia School

DRAWING TITLE:

Eshjaia School

List of Drawings

DESIGN: AA

DRAWN: AA

APPROVED: AA.

SHEET NO:


A000

DATE:

20-February-2016


SCALE:

1:100

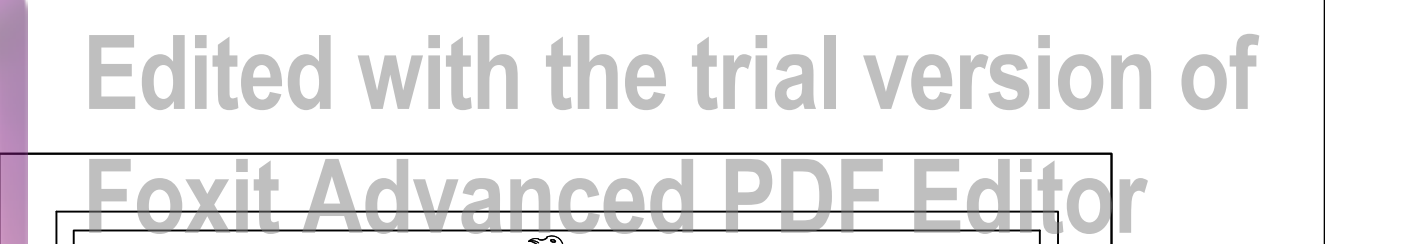

State of Palestine
Ministry of Education & Higher Education


NOTES :-

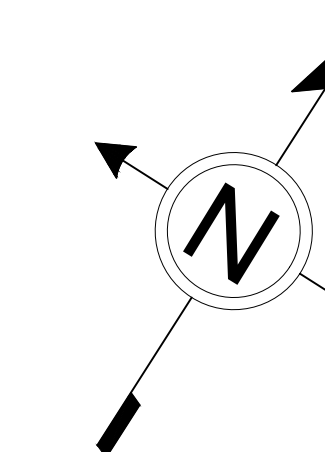
$$+ 0.00 = 35.90$$

 to be Demolished

 to be Dismantle

FUNDING BY:

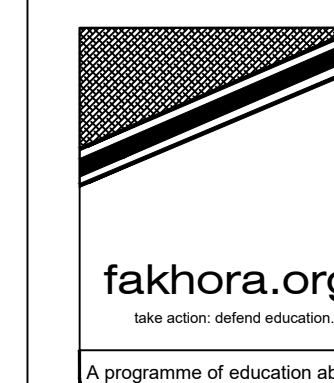

EMPLEMENTED BY:


50
YEARS

Empowered lives, Resilient nation

IN COOPERATION WITH:



CONSULTANT:

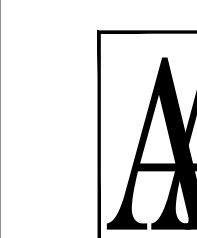

ABUSHAHLA & ASSOCIATES
"Consulting Engineers"
Palestine

+970-8-2864067 / +970-8-2828971

Eshijaia School

DRAWING TITLE:

Eshijaia School

DEMOLISH PLAN

DESIGN:	AA
---------	----

DATE:	20-February-2016
-------	------------------

DESIGN:	AA
DRAWN:	AA

DRAWN: AA
APPROVED: A.A.

SCALE:

SHEET NO

AD01



NOTES :-


Legend :

- Fake Grass
- Fake Grass
- Level
- Proposed tree
- Proposed tree
- Existing tree
- Existing tree
- Proposed Plants
- Rain pipes

- 1- Exist Class Room Building
- 2- Proposed CLASS ROOM BUILDING
- 3- EXIST Toilet
- 4- EXIT DISABLE TOILET
- 5- Proposed Canteen
- 6- Proposed STEEL SHED
- 7- Proposed MPH
- 8- Proposed PLAY GROUND
- 9- Drinking Fountain
- 10- GENERATOR ROOM
- 11- WATER TANKS ROOM

± 0.00 = 35.90

FUNDED BY:

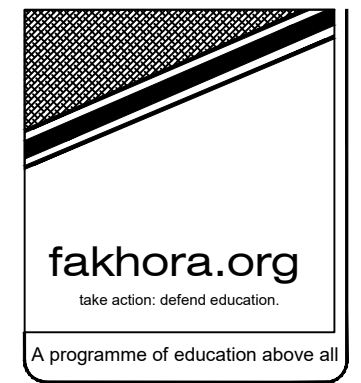

EMPLEMENTED BY:




Empowered lives, Resilient nation

IN COOPERATION WITH:



CONSULTANT:

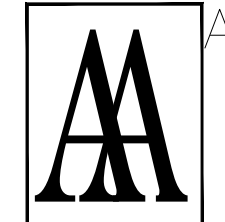

ABUSHAHLA & ASSOCIATES
"Consulting Engineers"
Palestine

+970-8-2864067 / +970-8-2828971

Eshijaia School

DRAWING TITLE:


Eshijaia School

SITE PLAN

DESIGN: AA	DATE: 20-February-2016
DRAWN: AA	SCALE: 1:100
APPROVED: A.A.	

SHEET NO:

A002

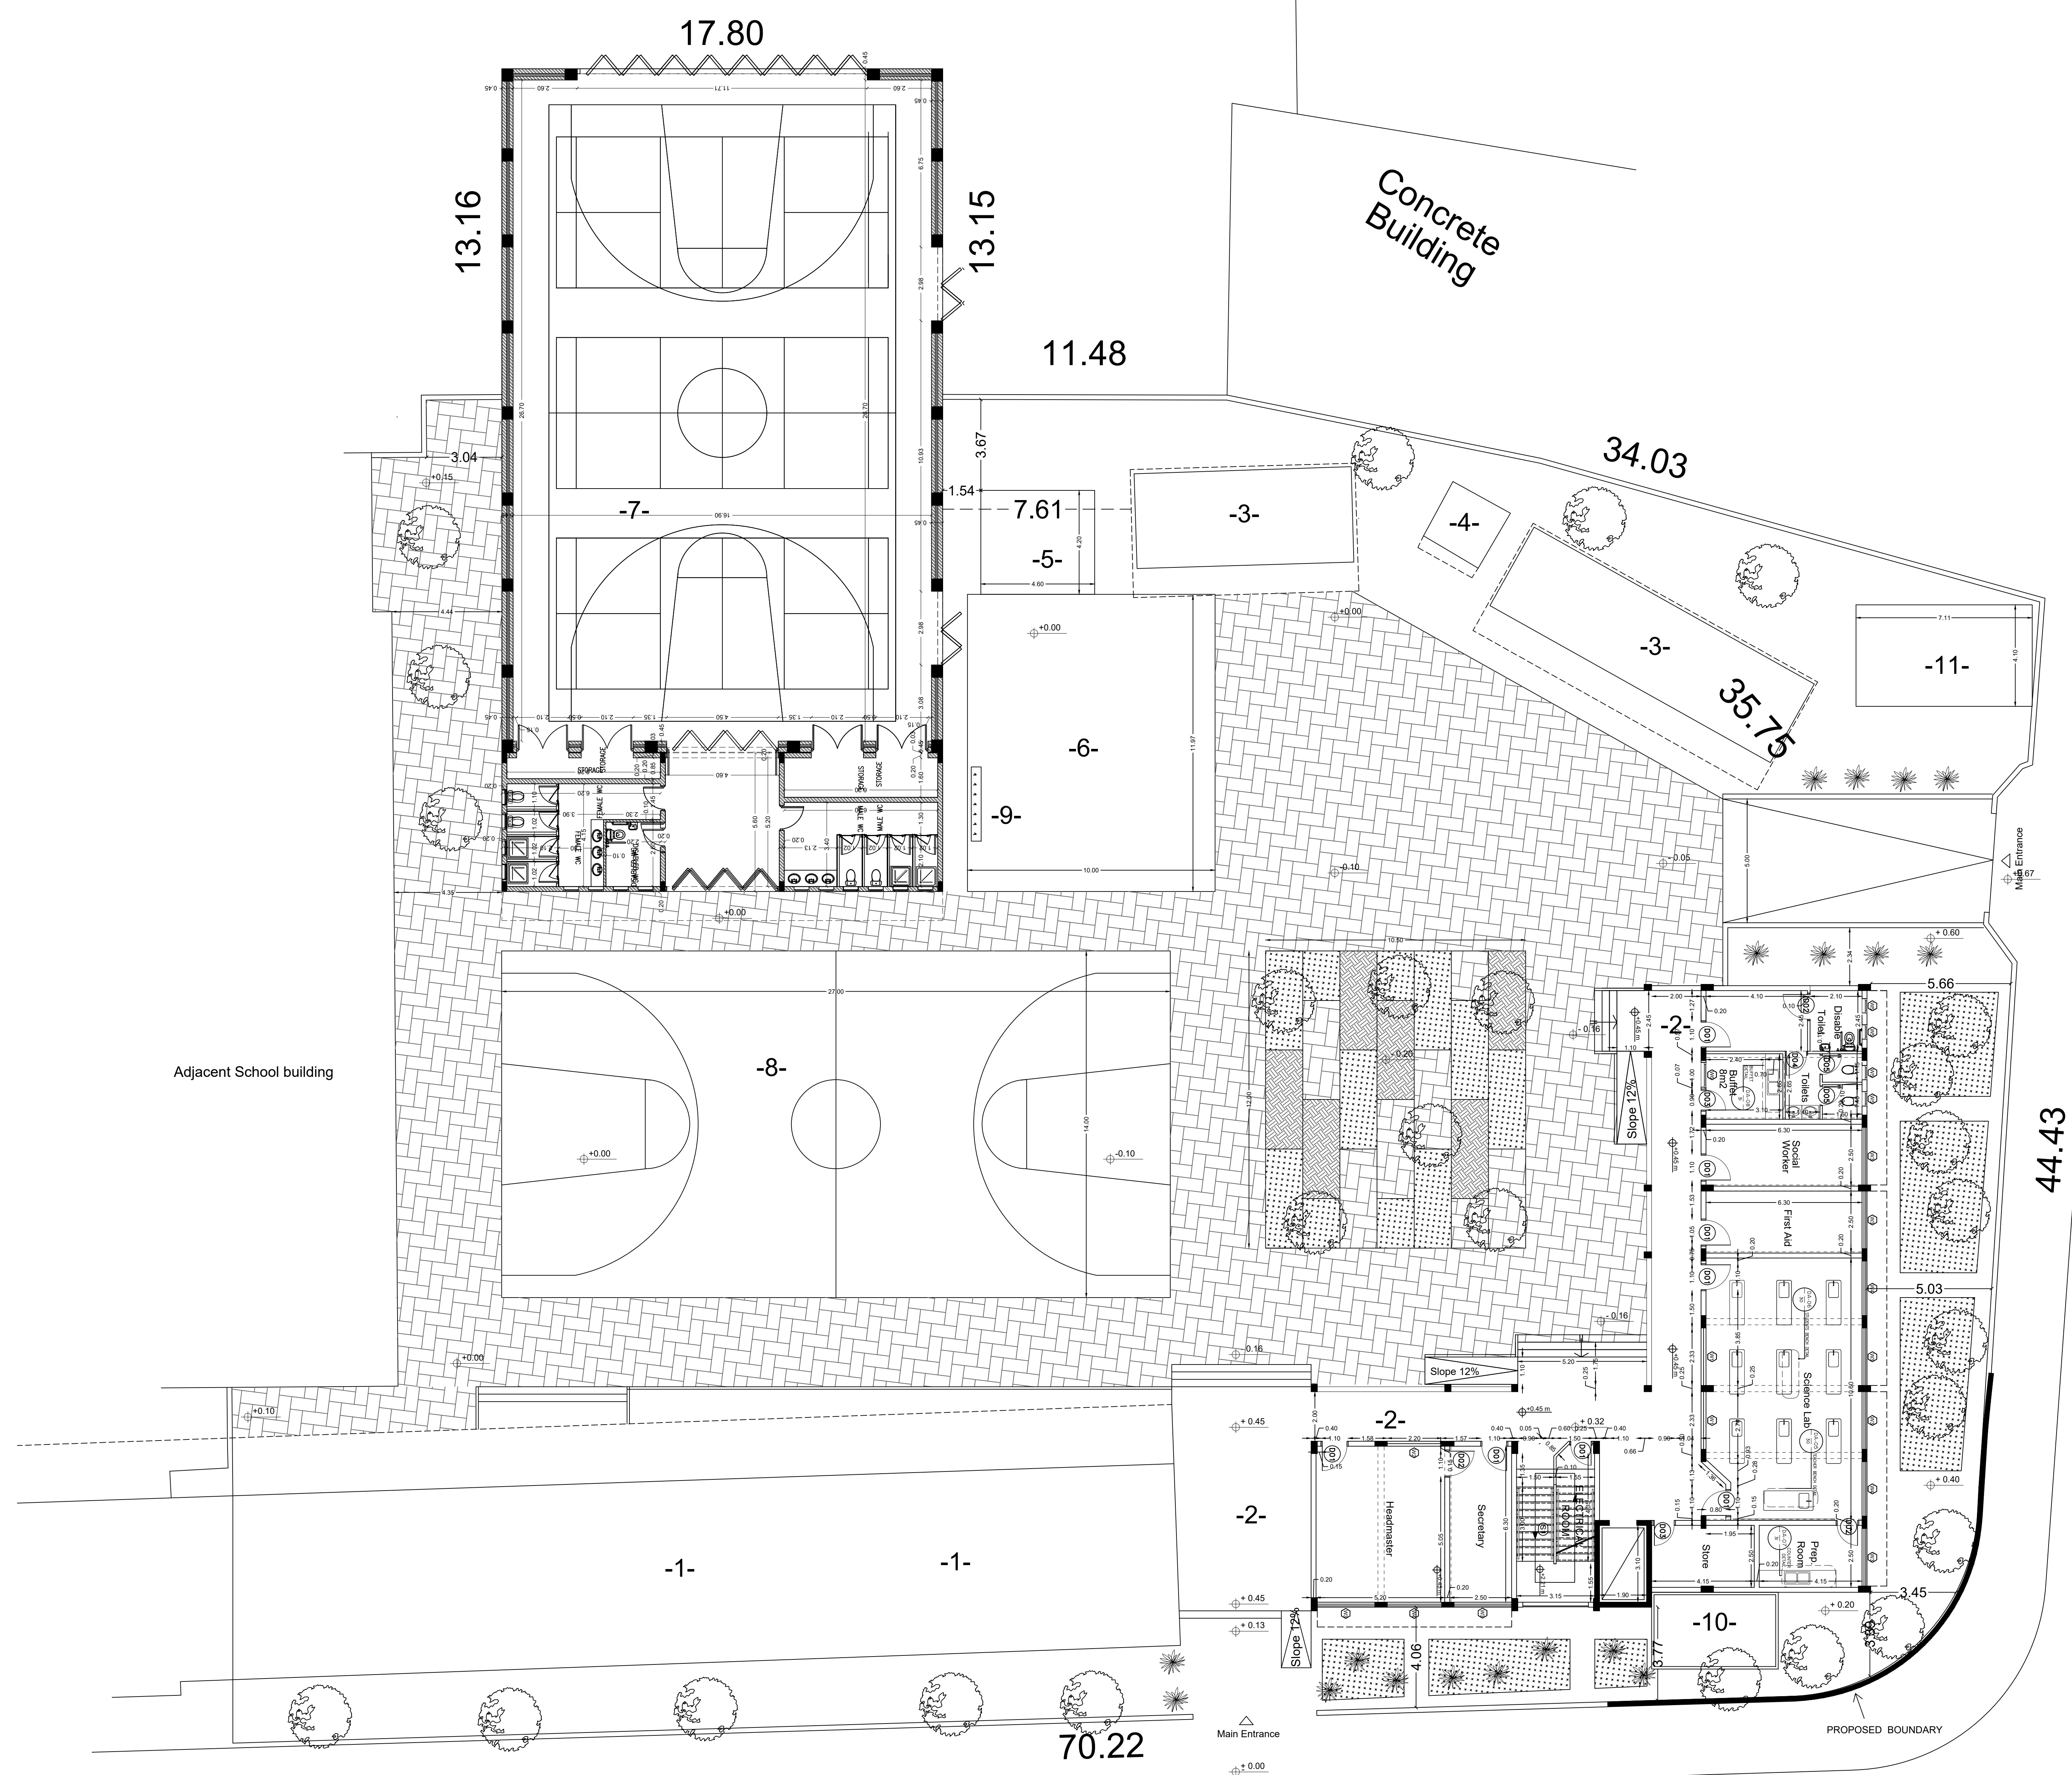



State of Palestine
Ministry of Education & Higher Education

NOTES :-

FUNDED BY:



EMPLEMENTED BY:



Empowered lives, Resilient nation

IN COOPERATION WITH:



CONSULTANT:



ABUSHAHLA & ASSOCIATES
"Consulting Engineers"
Palestine

+970-8-2864067 / +970-8-2828971

Eshjaia School

DRAWING TITLE:

Eshjaia School

Proposed Ground Floor Areas

DESIGN: AA

DRAWN: AA

APPROVED: AA

SHEET NO:

A003


DATE:

20-February-2016

SCALE:

1:100

GROUND FLOOR		
NO.	ITEM	AREA
1	GROUND FLOOR	290.00
2	STAIR CASE	19.84
3	Left	5.89
	TOTAL	315.73

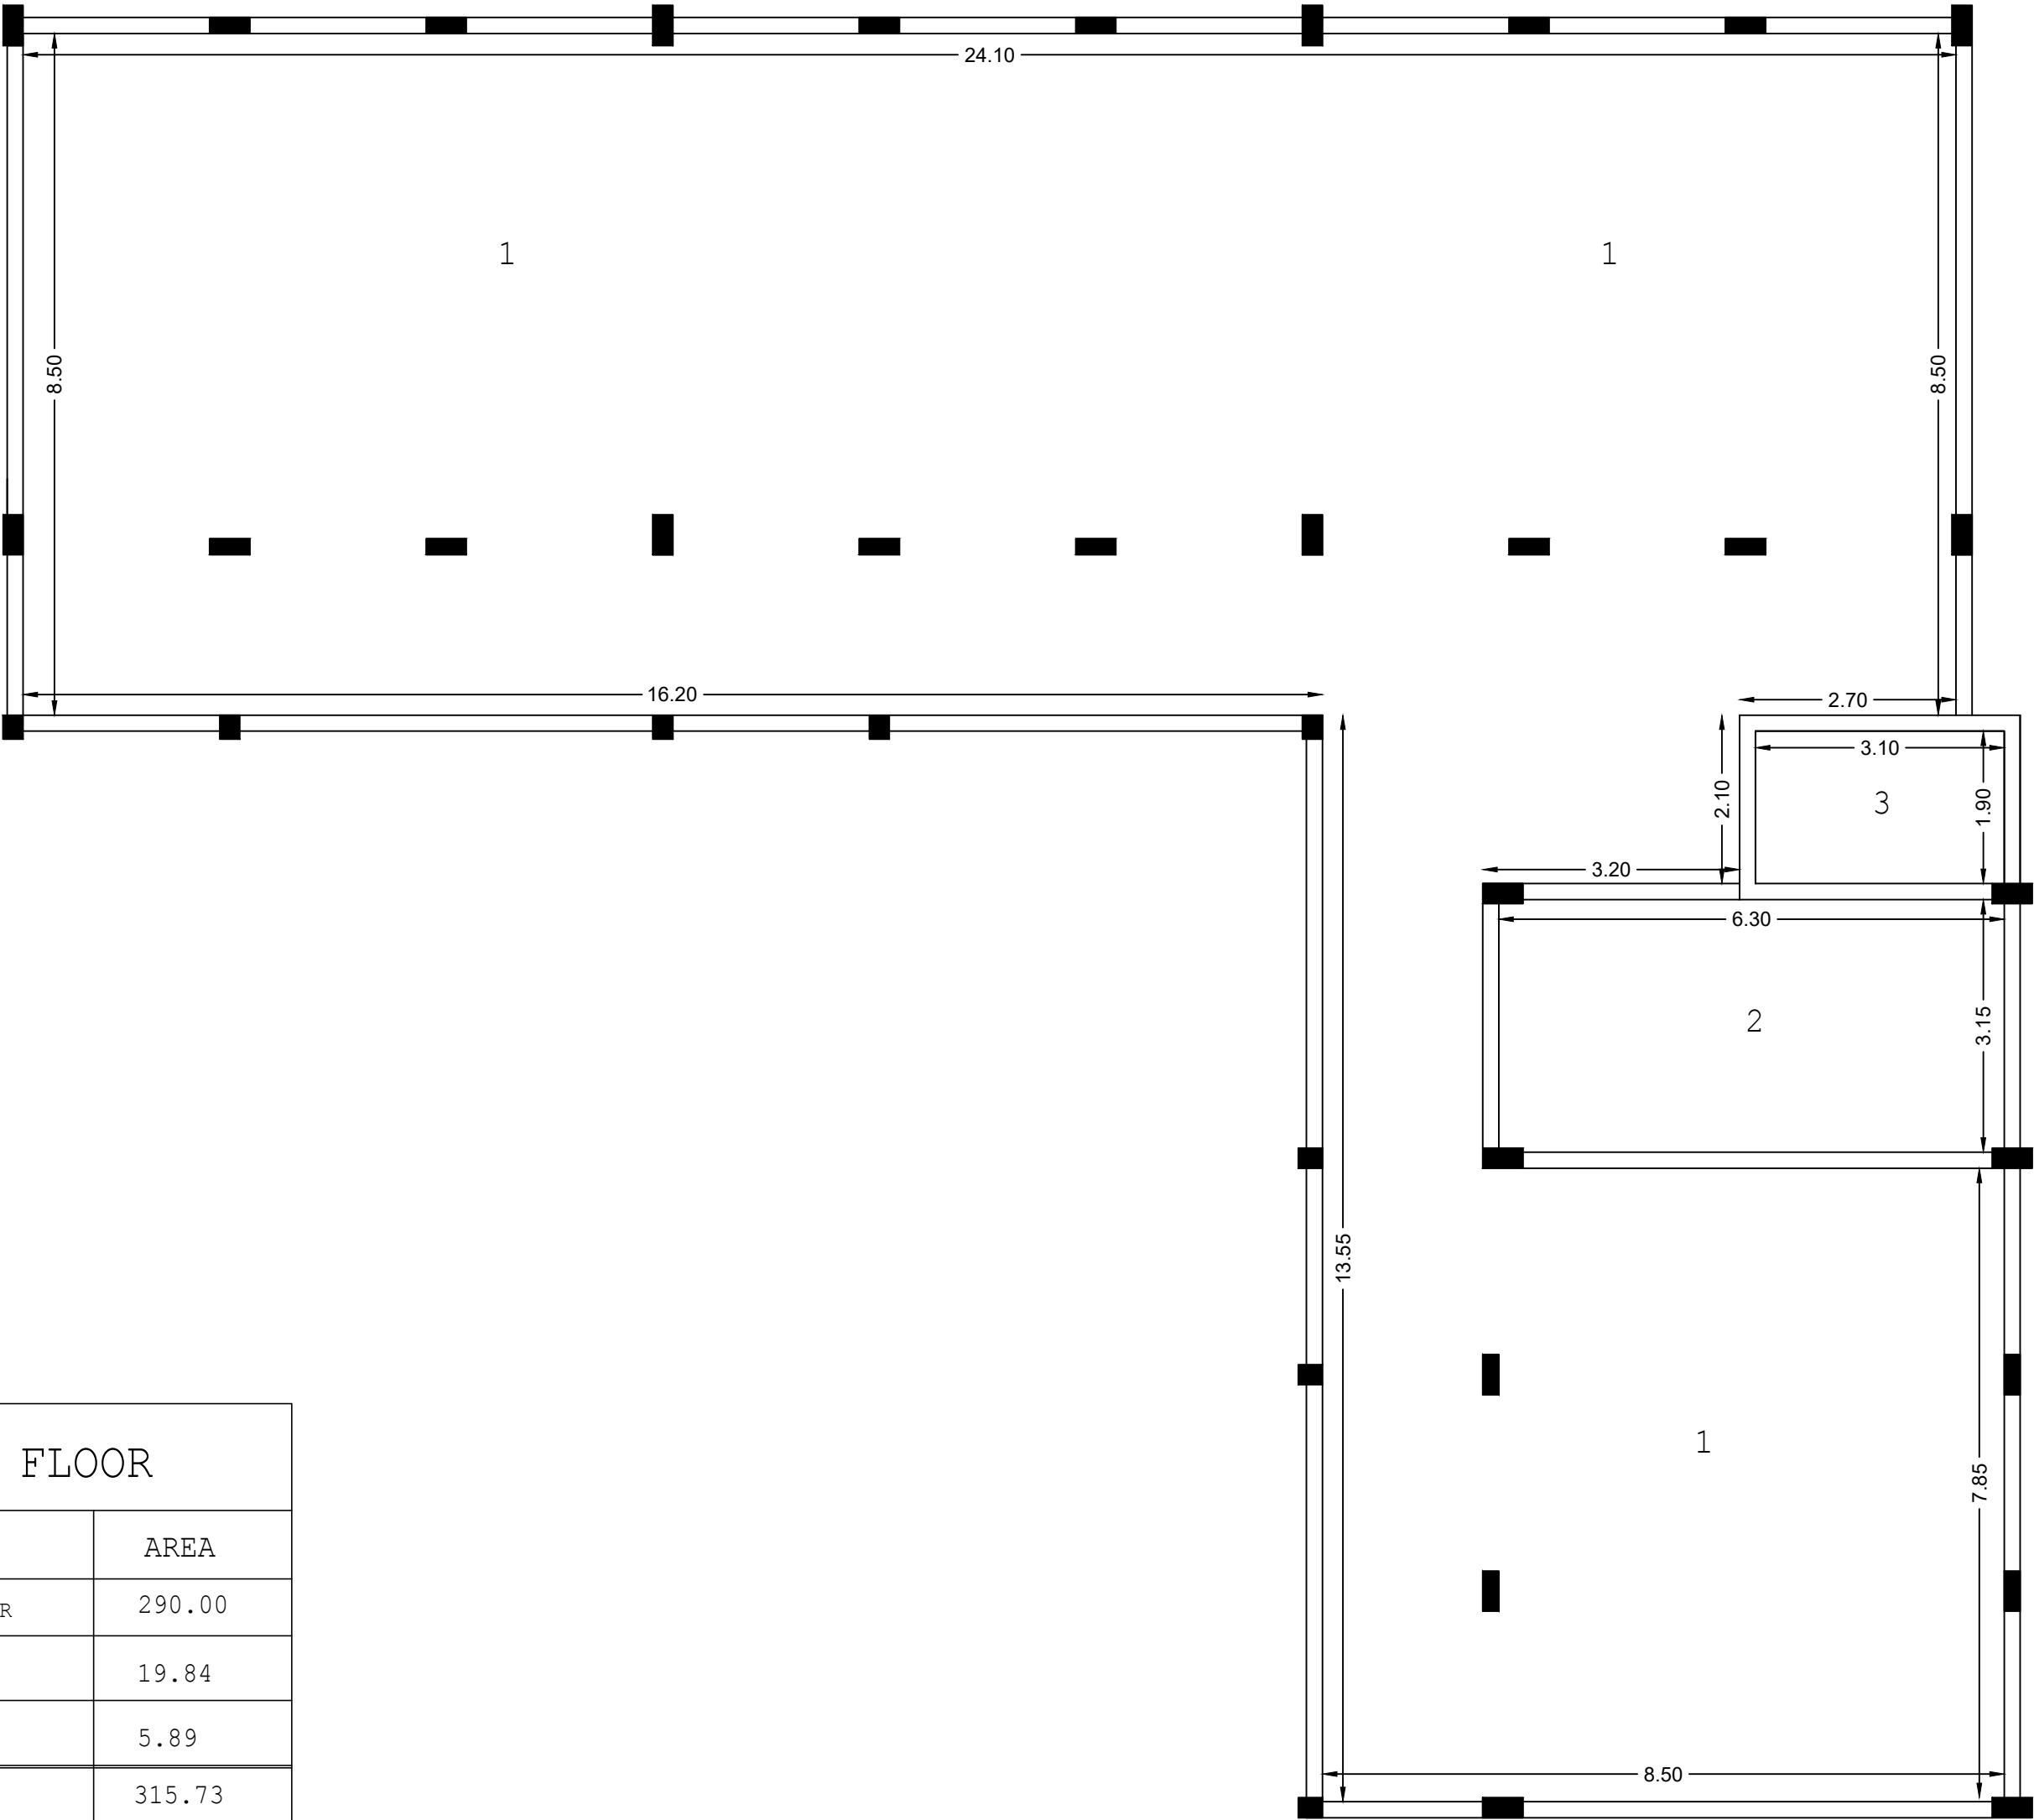



State of Palestine
Ministry of Education & Higher Education

NOTES :-

FUNDED BY:



EMPLEMENTED BY:



Empowered lives, Resilient nation

IN COOPERATION WITH:



CONSULTANT:



ABUSHAHLA & ASSOCIATES
"Consulting Engineers"
Palestine

+970-8-2864067 / +970-8-2828971

Eshjaia School

DRAWING TITLE:

Eshjaia School

Proposed First Floor Areas

DESIGN: AA

DRAWN: AA

APPROVED: AA

SHEET NO:

A004


DATE:

20-February-2016

SCALE:

1:100

First FLOOR		
NO.	ITEM	AREA
1	GROUND FLOOR	290.00
2	STAIR CASE	19.84
3	Left	5.89
	TOTAL	315.73

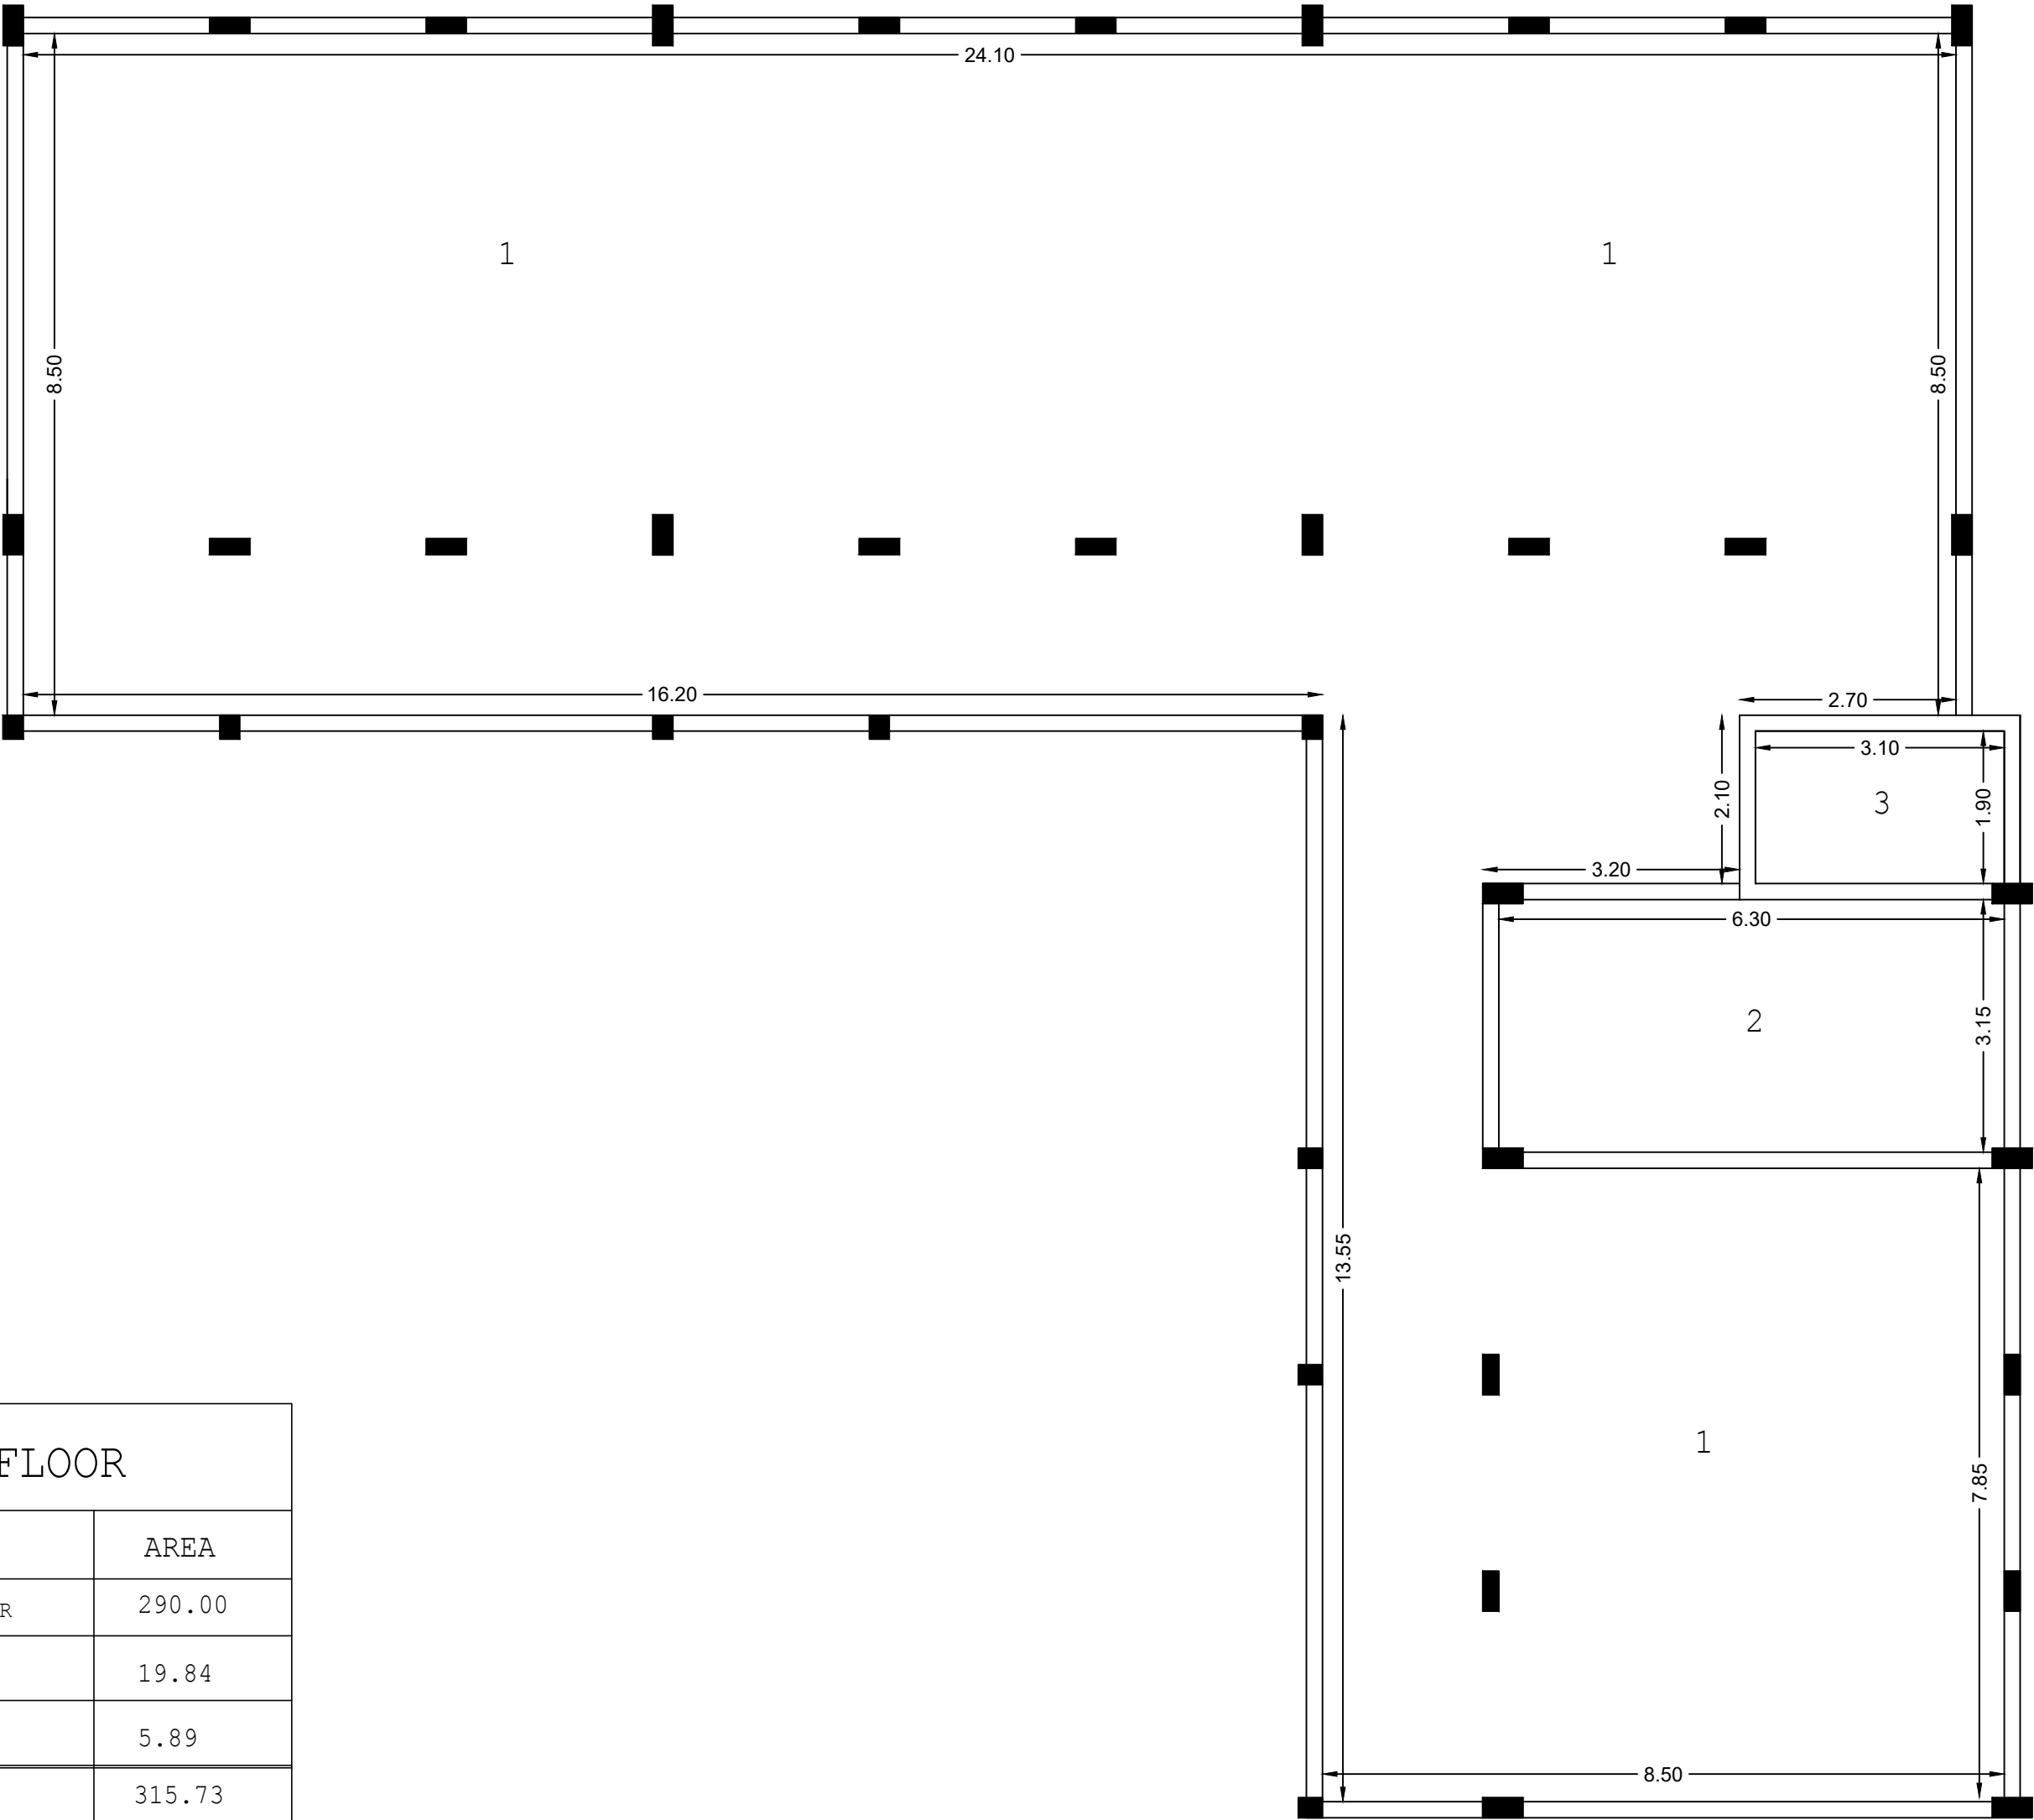



State of Palestine
Ministry of Education & Higher Education

NOTES :-

FUNDED BY:



EMPLEMENTED BY:



Empowered lives, Resilient nation

IN COOPERATION WITH:



CONSULTANT:



ABUSHAHLA & ASSOCIATES
"Consulting Engineers"
Palestine

+970-8-2864067 / +970-8-2828971

Eshjaia School

DRAWING TITLE:

Eshjaia School

Proposed Second Floor Areas

DESIGN: AA

DRAWN: AA

APPROVED: AA

SHEET NO:

A005


DATE:

20-February-2016

SCALE:

1:100

Second FLOOR		
NO.	ITEM	AREA
1	GROUND FLOOR	290.00
2	STAIR CASE	19.84
3	Left	5.89
	TOTAL	315.73

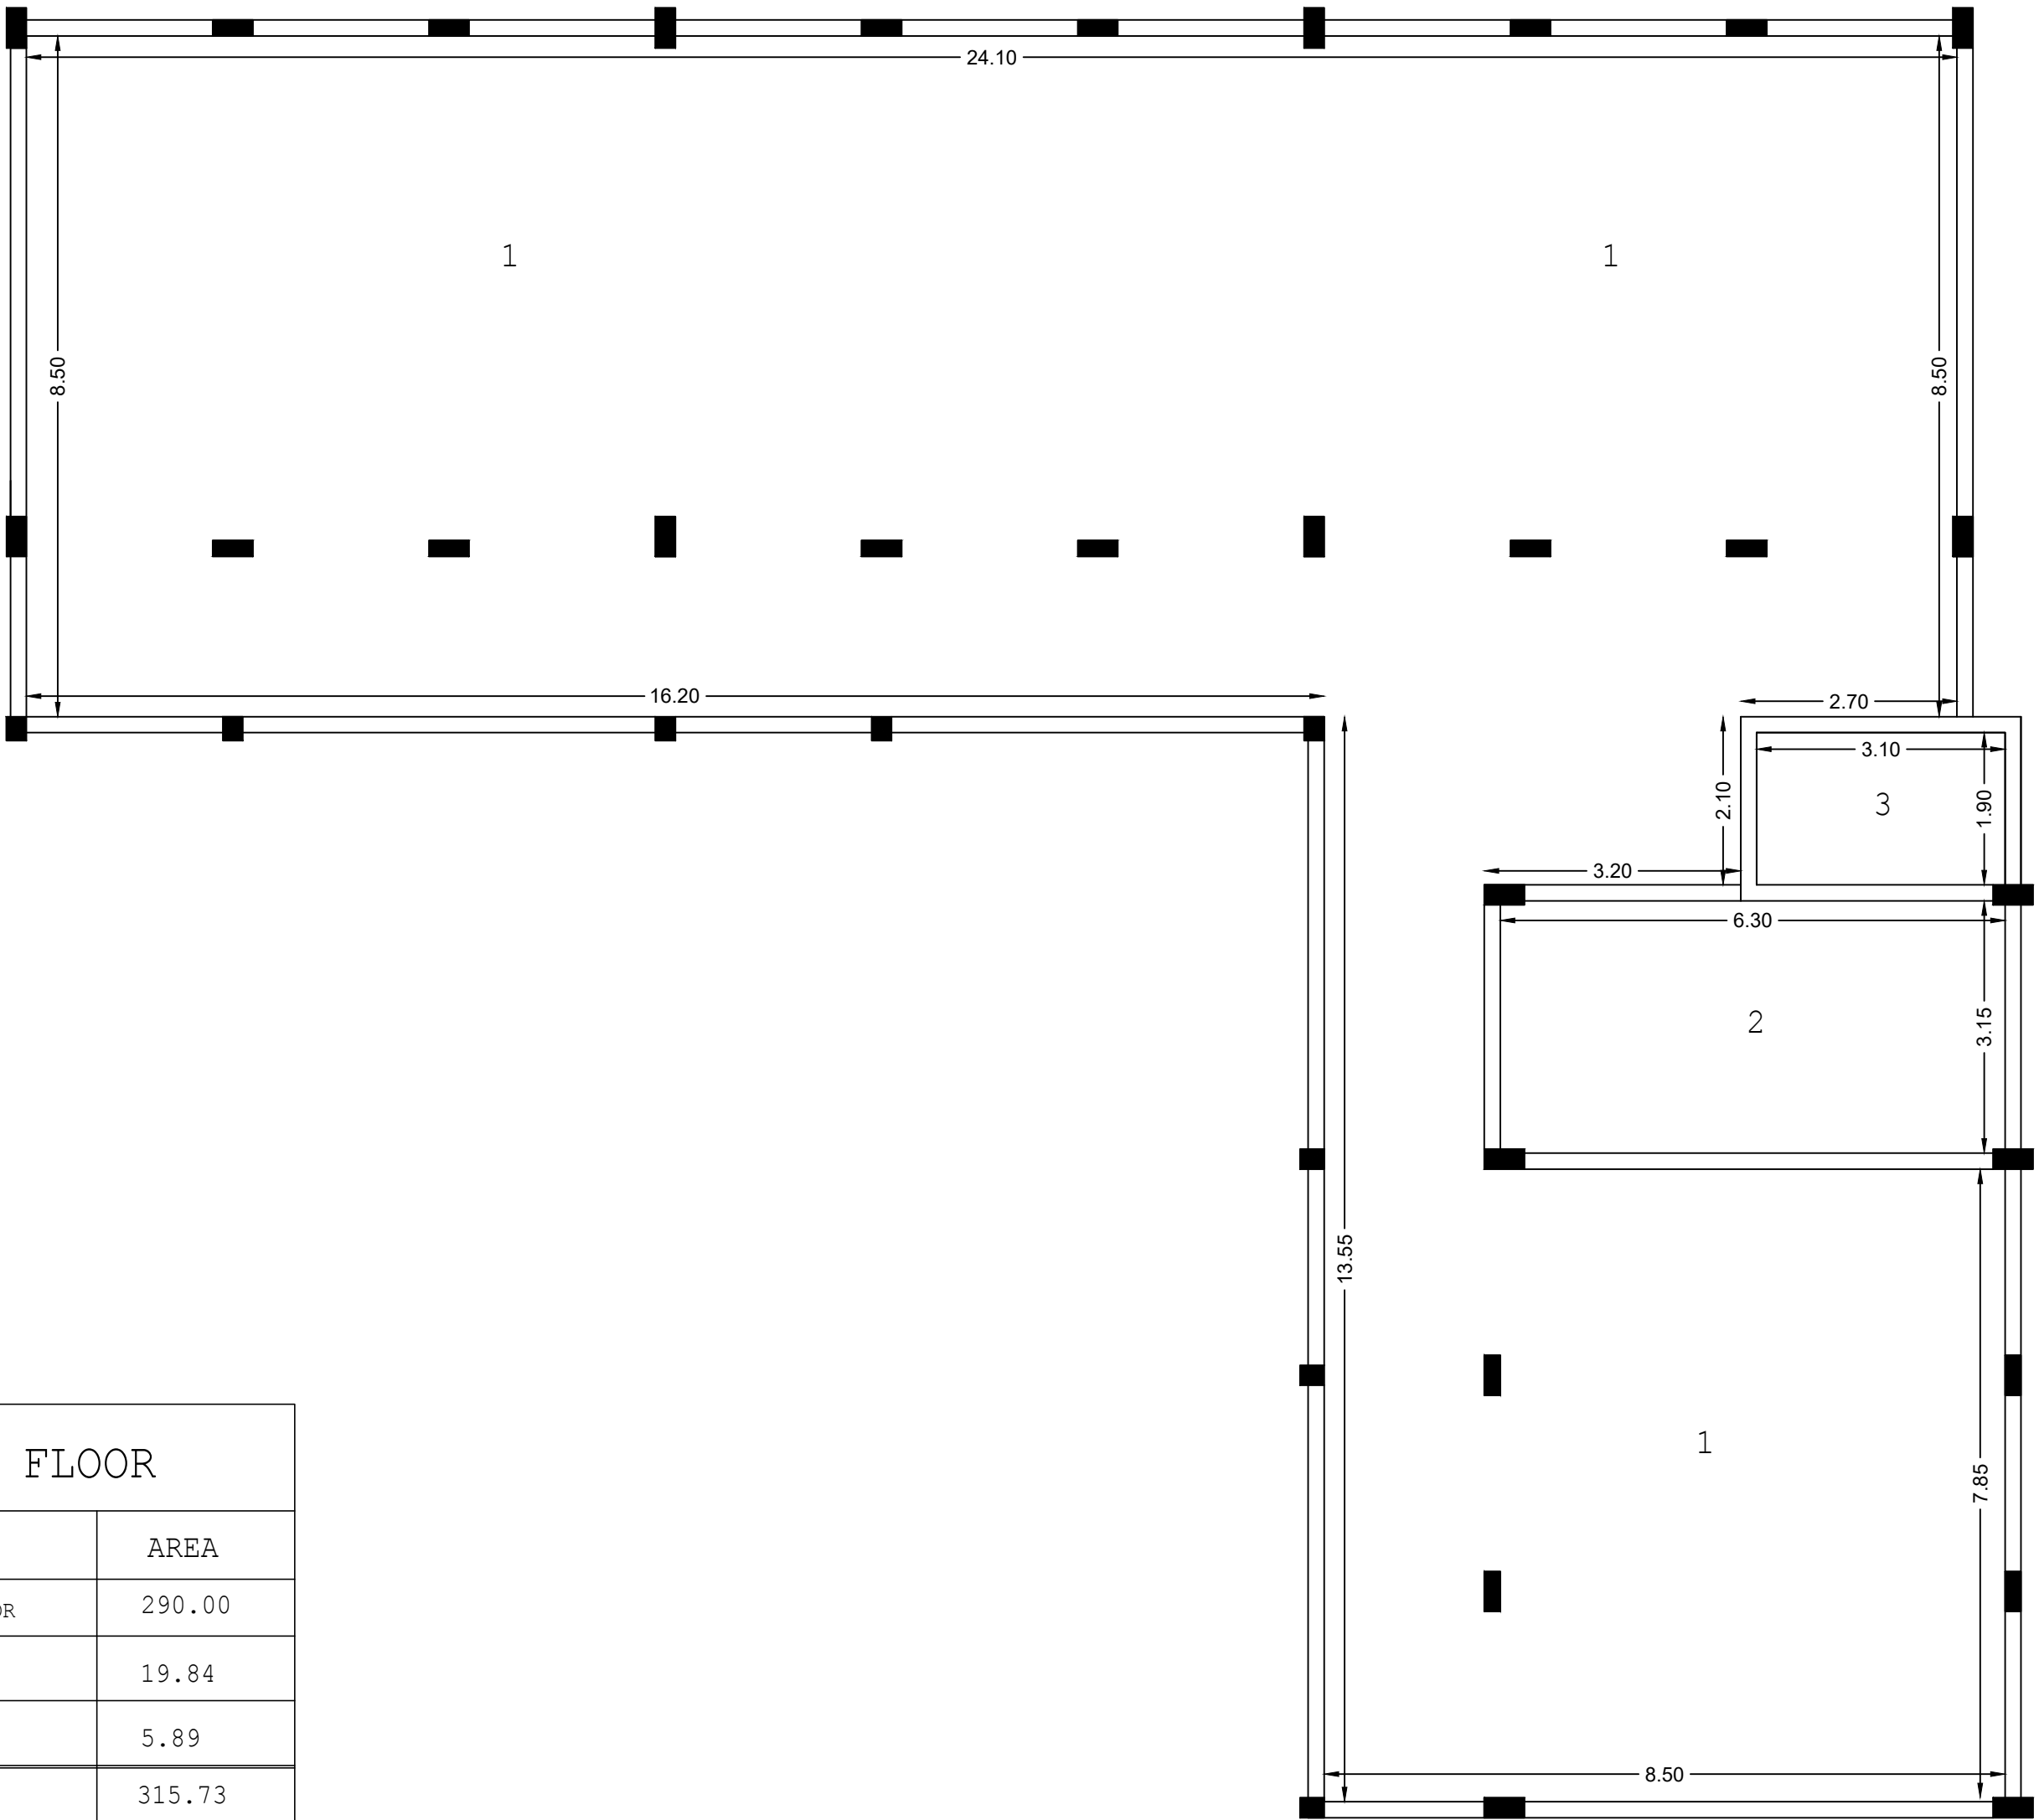



State of Palestine
Ministry of Education & Higher Education

NOTES :-

FUNDED BY:



EMPLEMENTED BY:



IN COOPERATION WITH:



CONSULTANT:



ABUSHAHLA & ASSOCIATES
"Consulting Engineers"
Palestine

+970-8-2864067 / +970-8-2828971

Eshijaia School

DRAWING TITLE:

Eshijaia School

Proposed Third Floor Areas

DESIGN: AA

DRAWN: AA

APPROVED: AA

SHEET NO:

A006


DATE:

20-February-2016

SCALE:


1:100

Third FLOOR		
NO.	ITEM	AREA
1	GROUND FLOOR	290.00
2	STAIR CASE	19.84
3	Left	5.89
	TOTAL	315.73

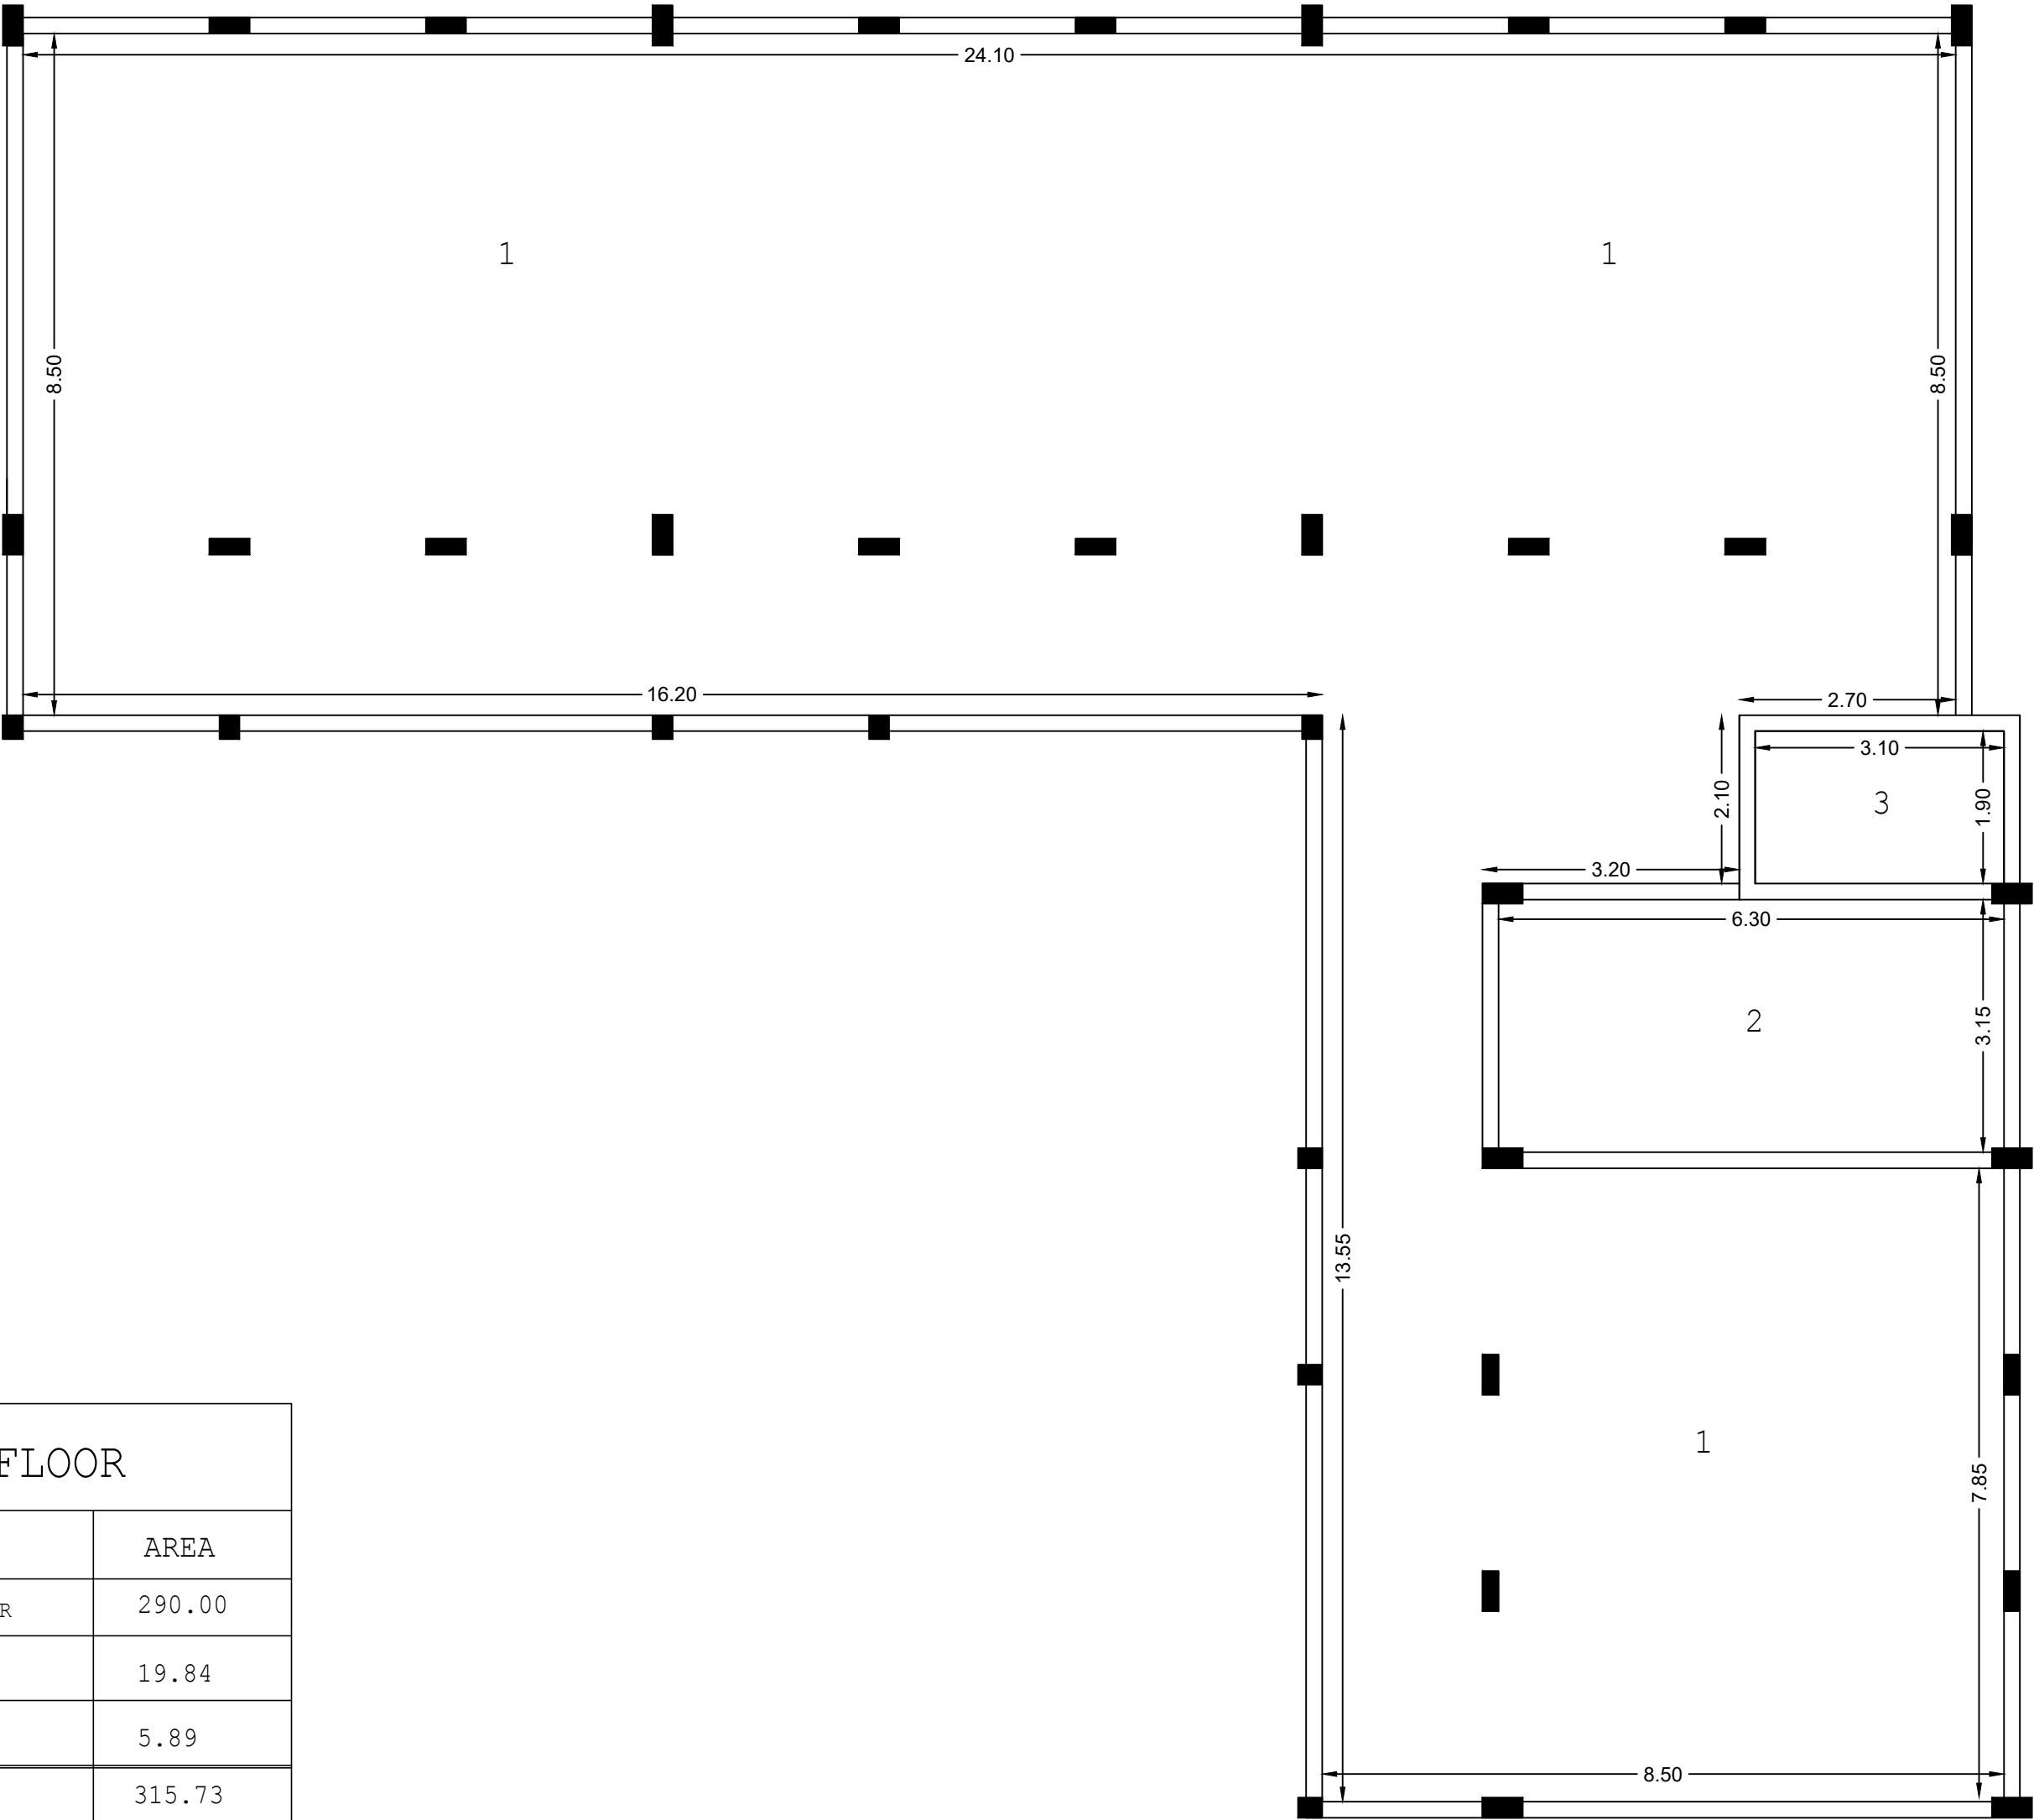



NOTES :-

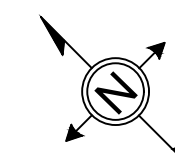

FUNDED BY:



EMPLEMENTED BY:



IN COOPERATION WITH:



CONSULTANT:



+970-8-2864067 / +970-8-2828971

Eshjaia School

DRAWING TITLE:

Eshjaia School

Proposed Ground Floor

DESIGN: AA

DRAWN: AA


APPROVED: AA

SHEET NO:

A007

DATE:
20-February-2016

SCALE:
1:100

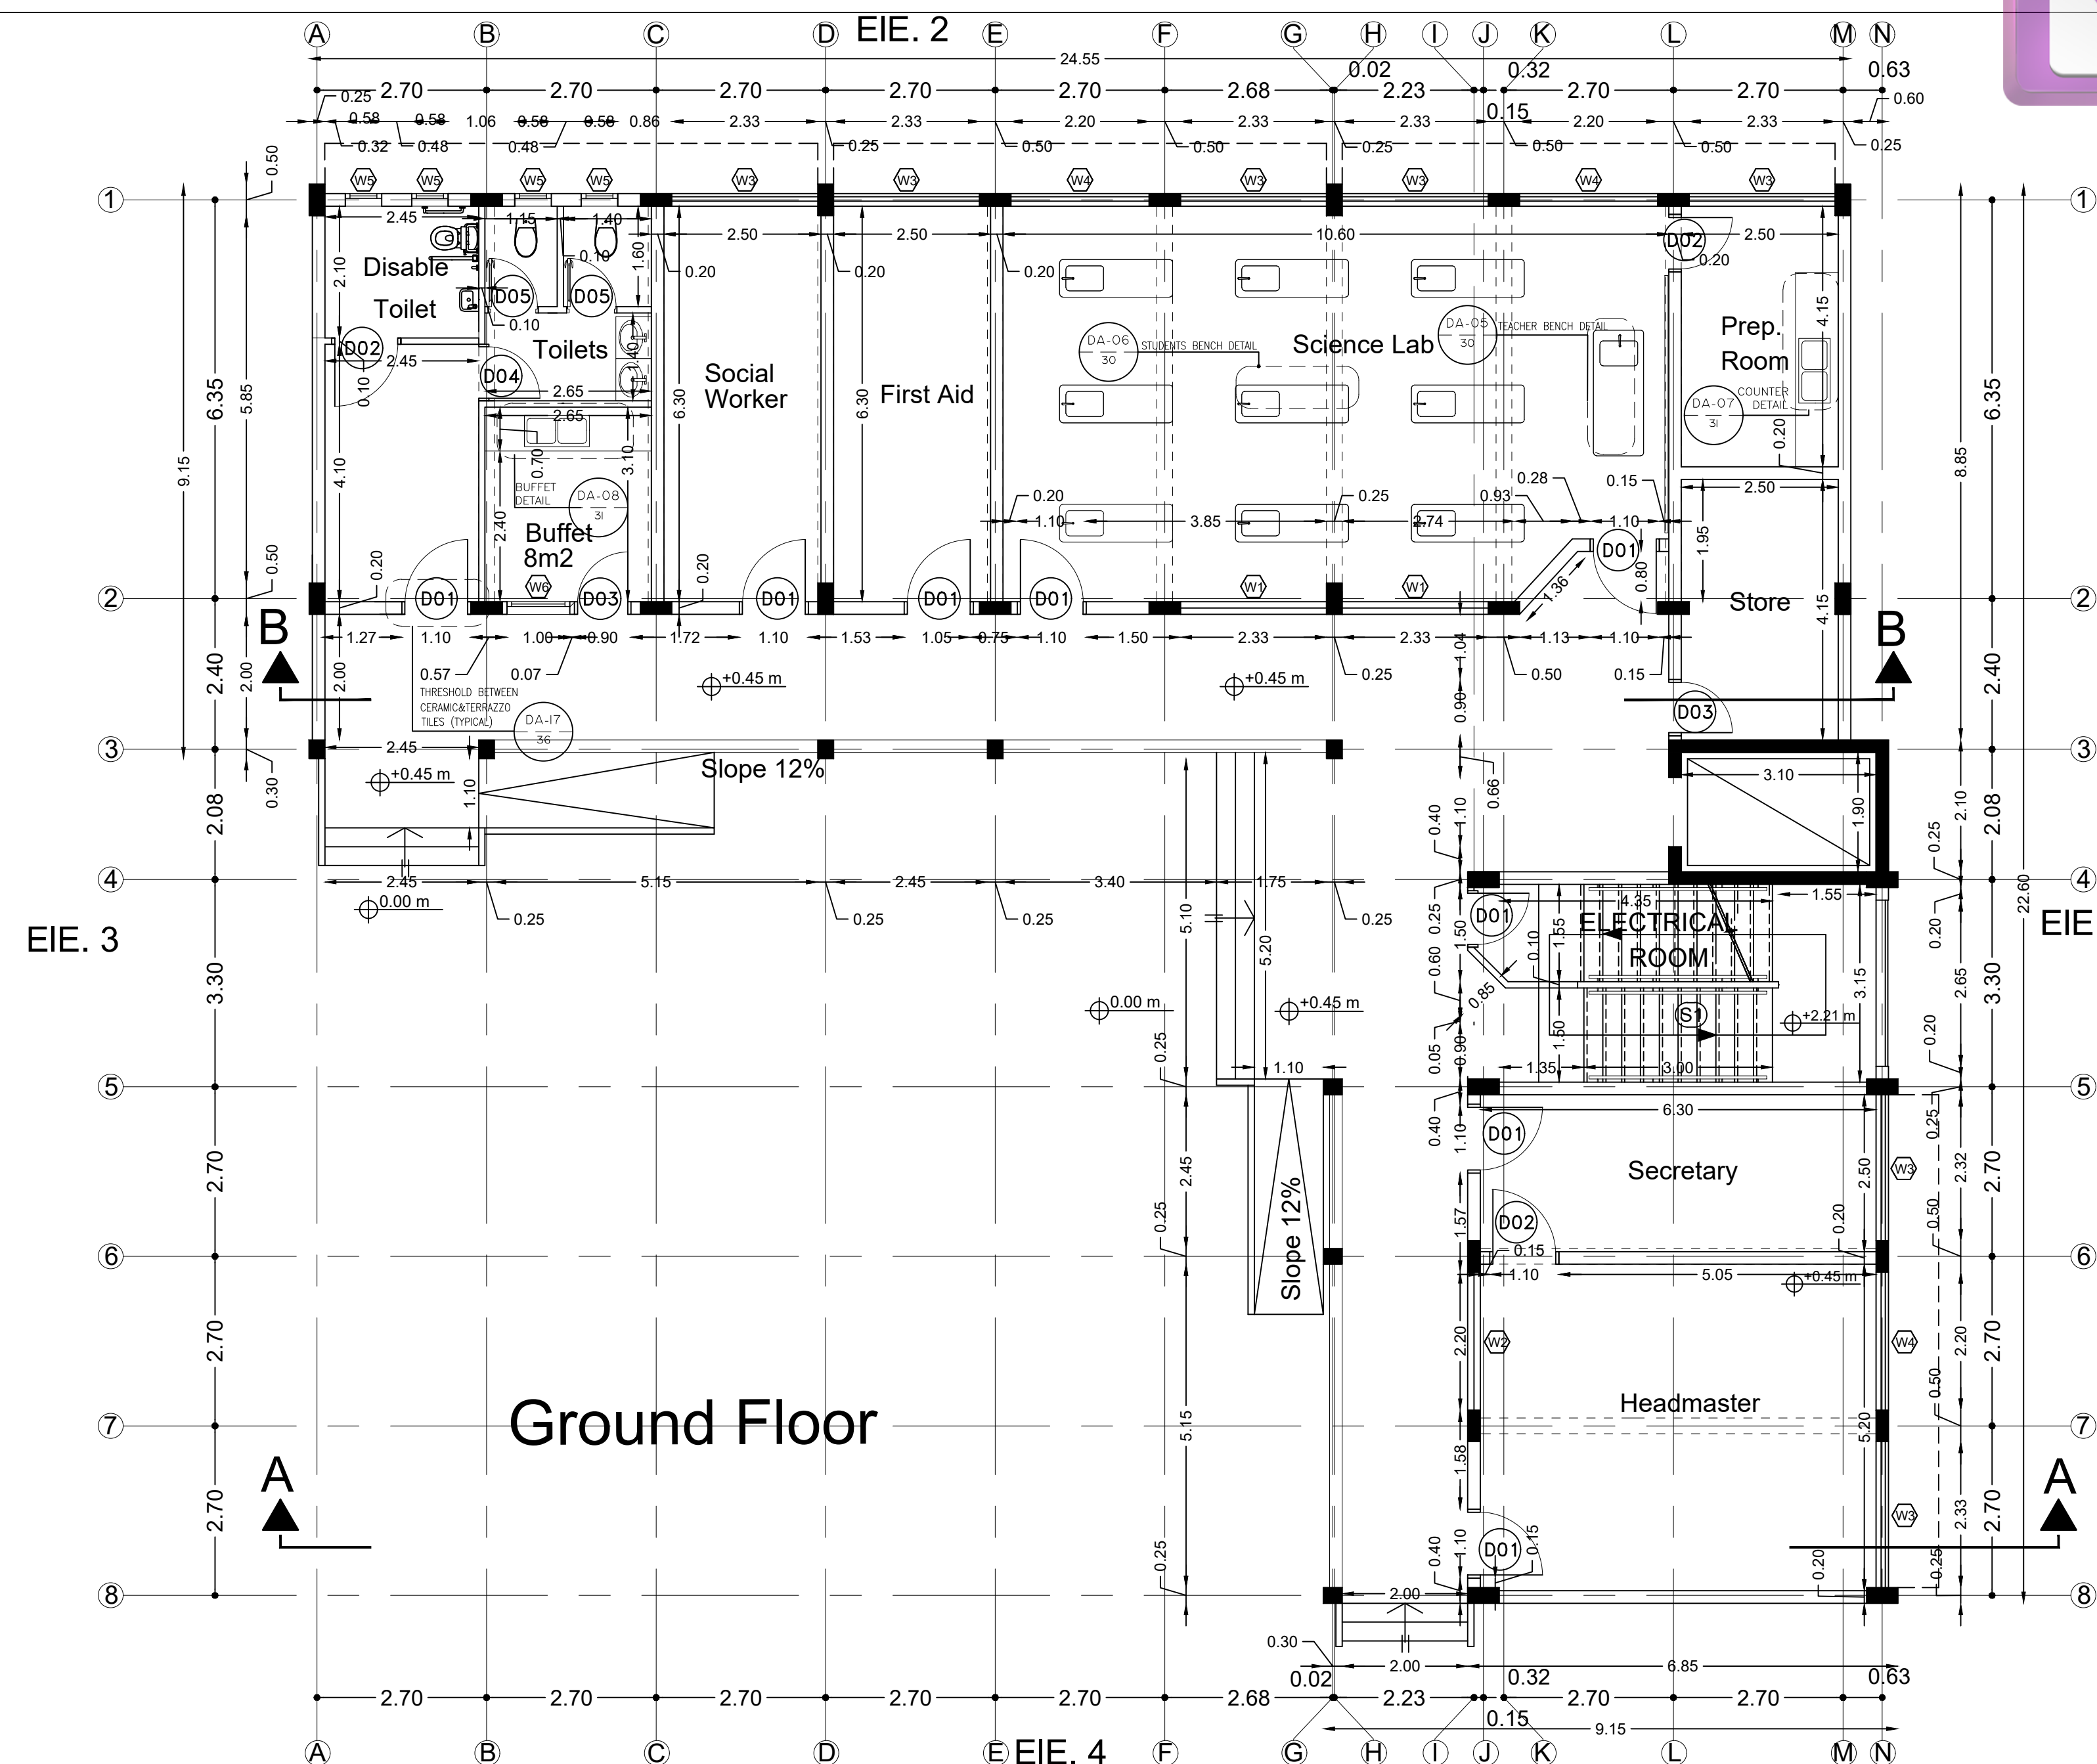




Edited with the trial version of
Foxit Advanced PDF Editor

To remove this notice, visit:

www.foxitsoftware.com/shopping

State of Palestine
Ministry of Education & Higher Education

NOTES :-

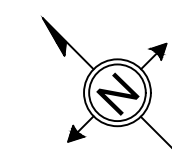

FUNDED BY:




EMPLEMENTED BY:



IN COOPERATION WITH:



CONSULTANT:

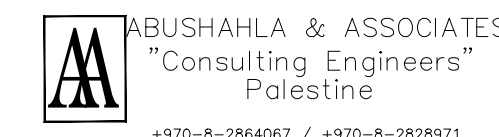

+970-8-2864067 / +970-8-2828971

Eshjaia School

DRAWING TITLE:

Eshjaia School

Proposed First Floor

DESIGN: AA

DRAWN: AA

APPROVED: AA

SHEET NO:


A008

DATE:

20-February-2016


SCALE:

1:100

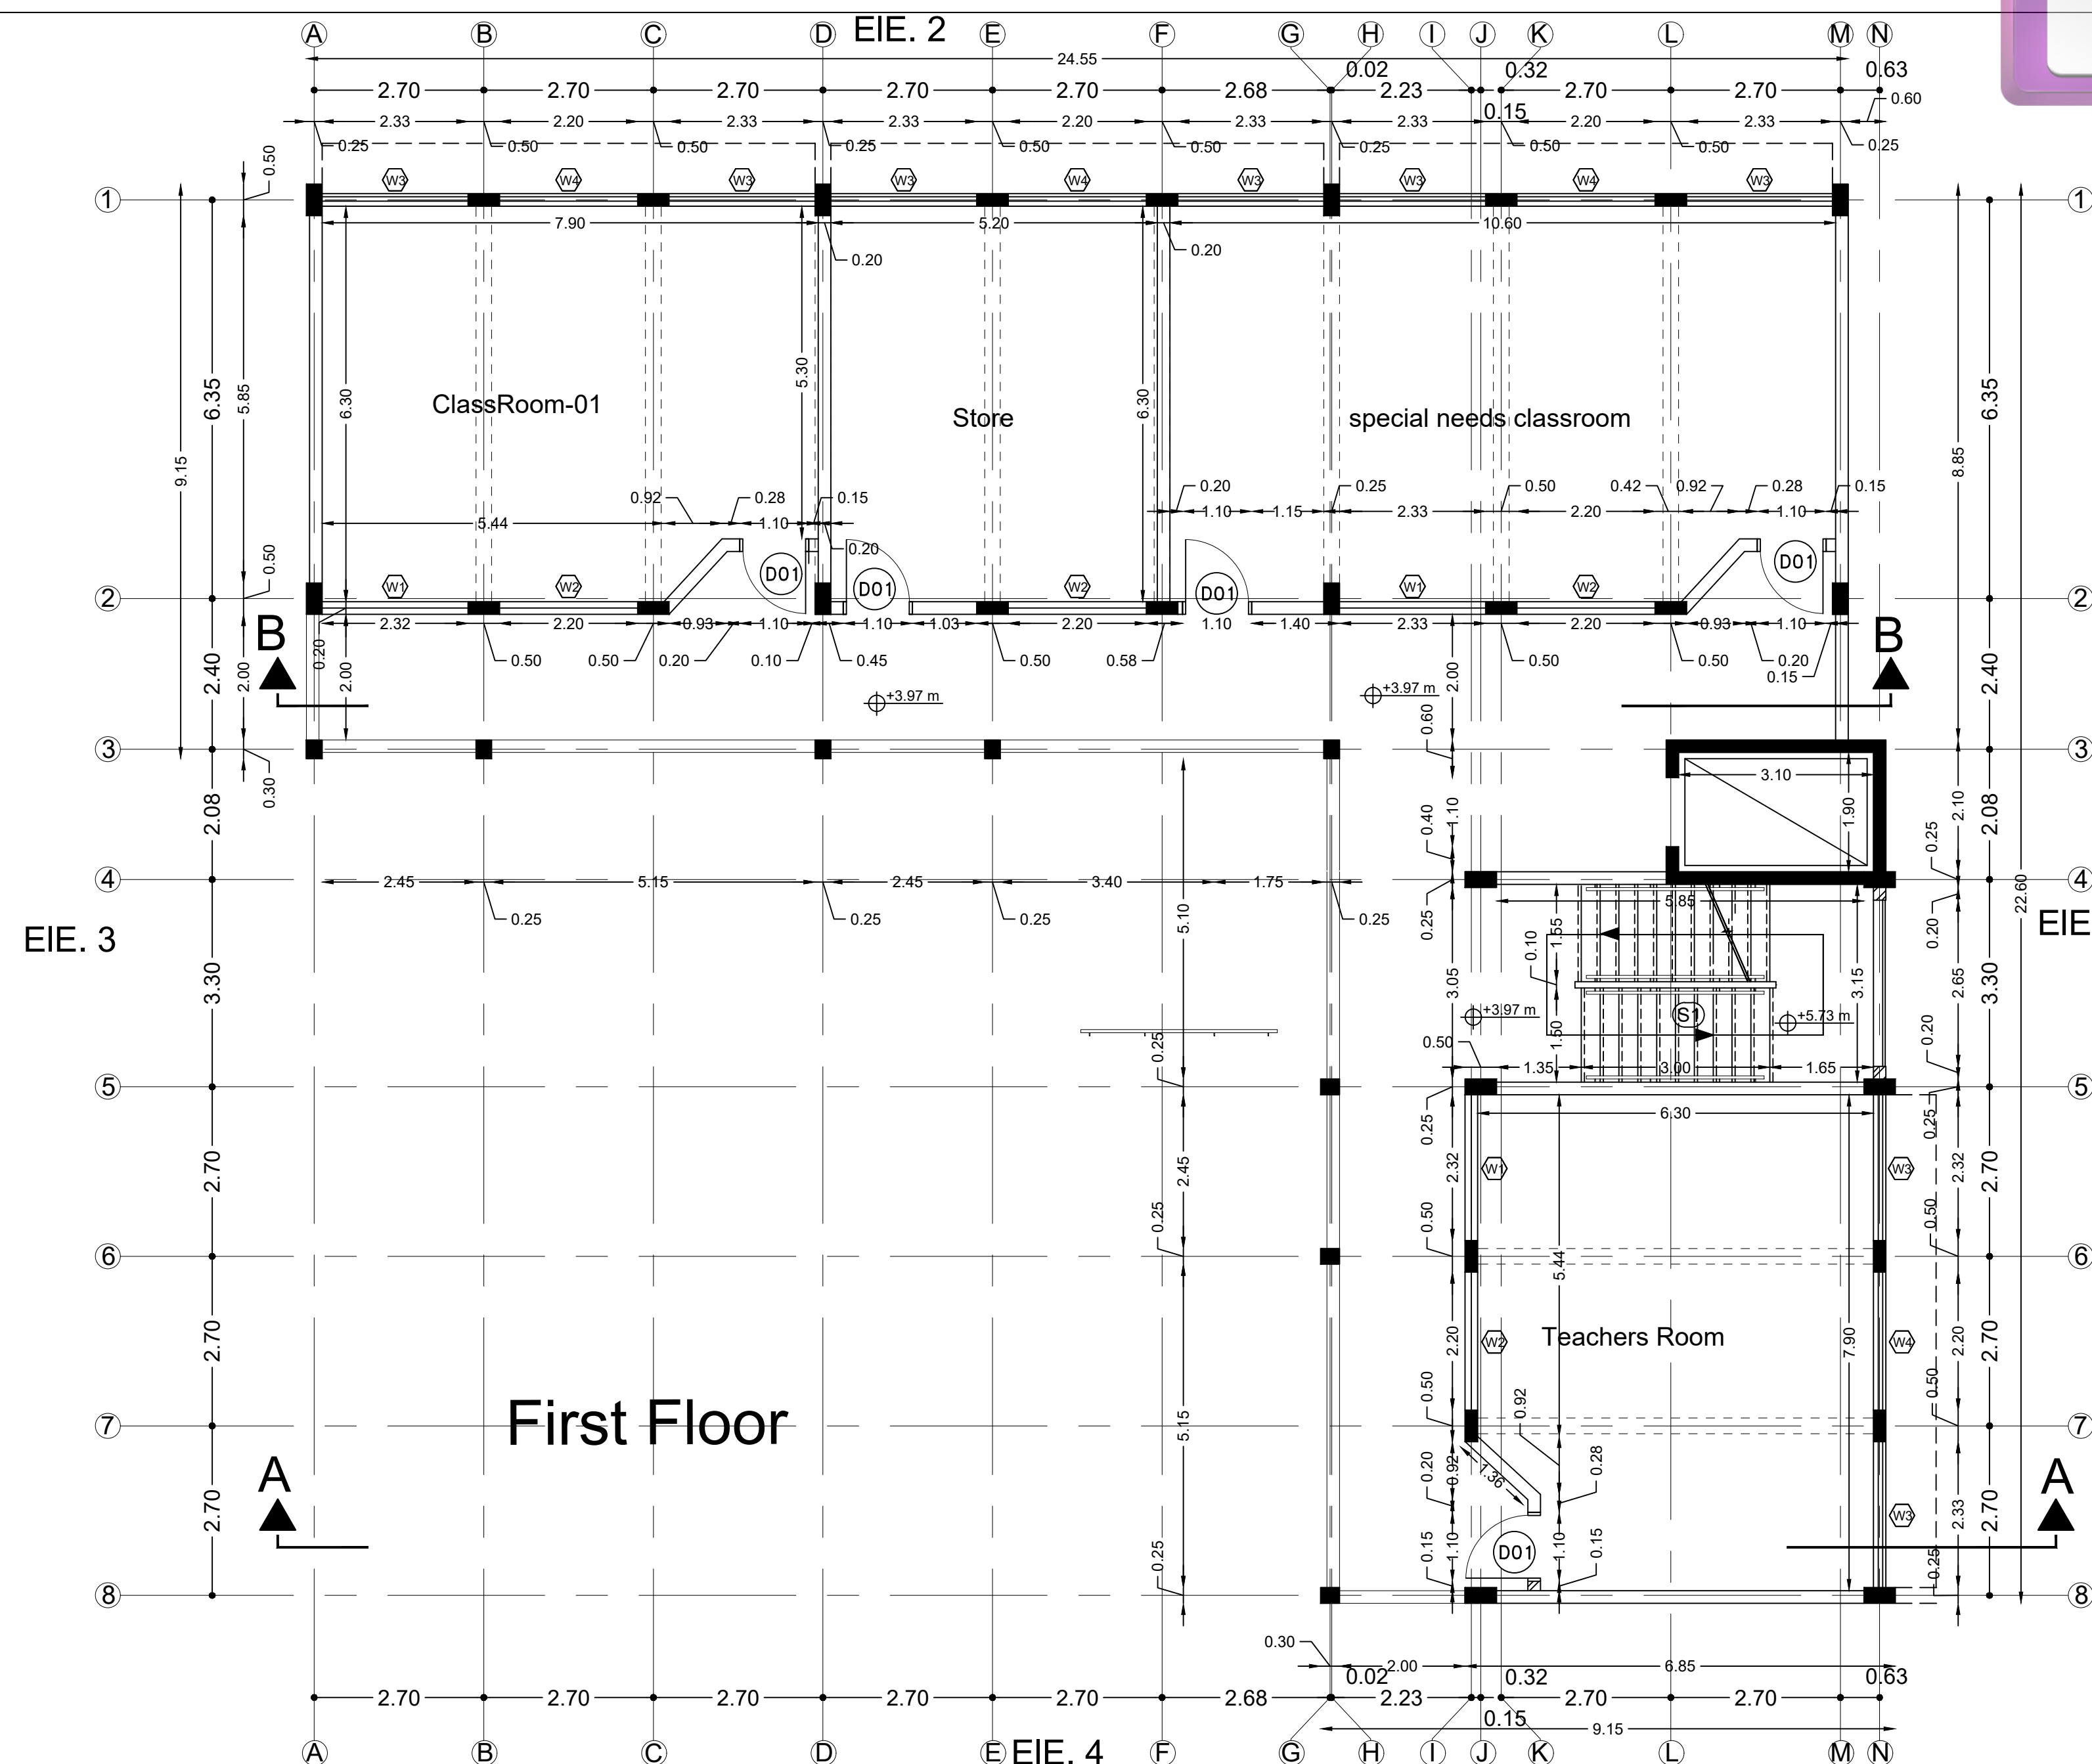




NOTES :-

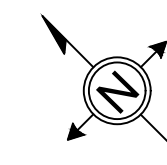

FUNDED BY:

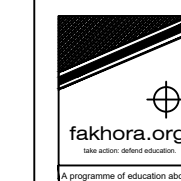

EMPLEMENTED BY:



50
YEARS

Empowered lives, Resilient nation

IN COOPERATION WITH:



CONSULTANT:



ABUSHAHLA & ASSOCIATES
"Consulting Engineers"
Palestine

+970-8-2864067 / +970-8-2828971

Eshijaia School

DRAWING TITLE:

Eshijaia School

Proposed Second Floor

DESIGN: AA

DRAWN: AA

APPROVED: AA

SHEET NO:


A009

DATE:

20-February-2016


SCALE:

1:100

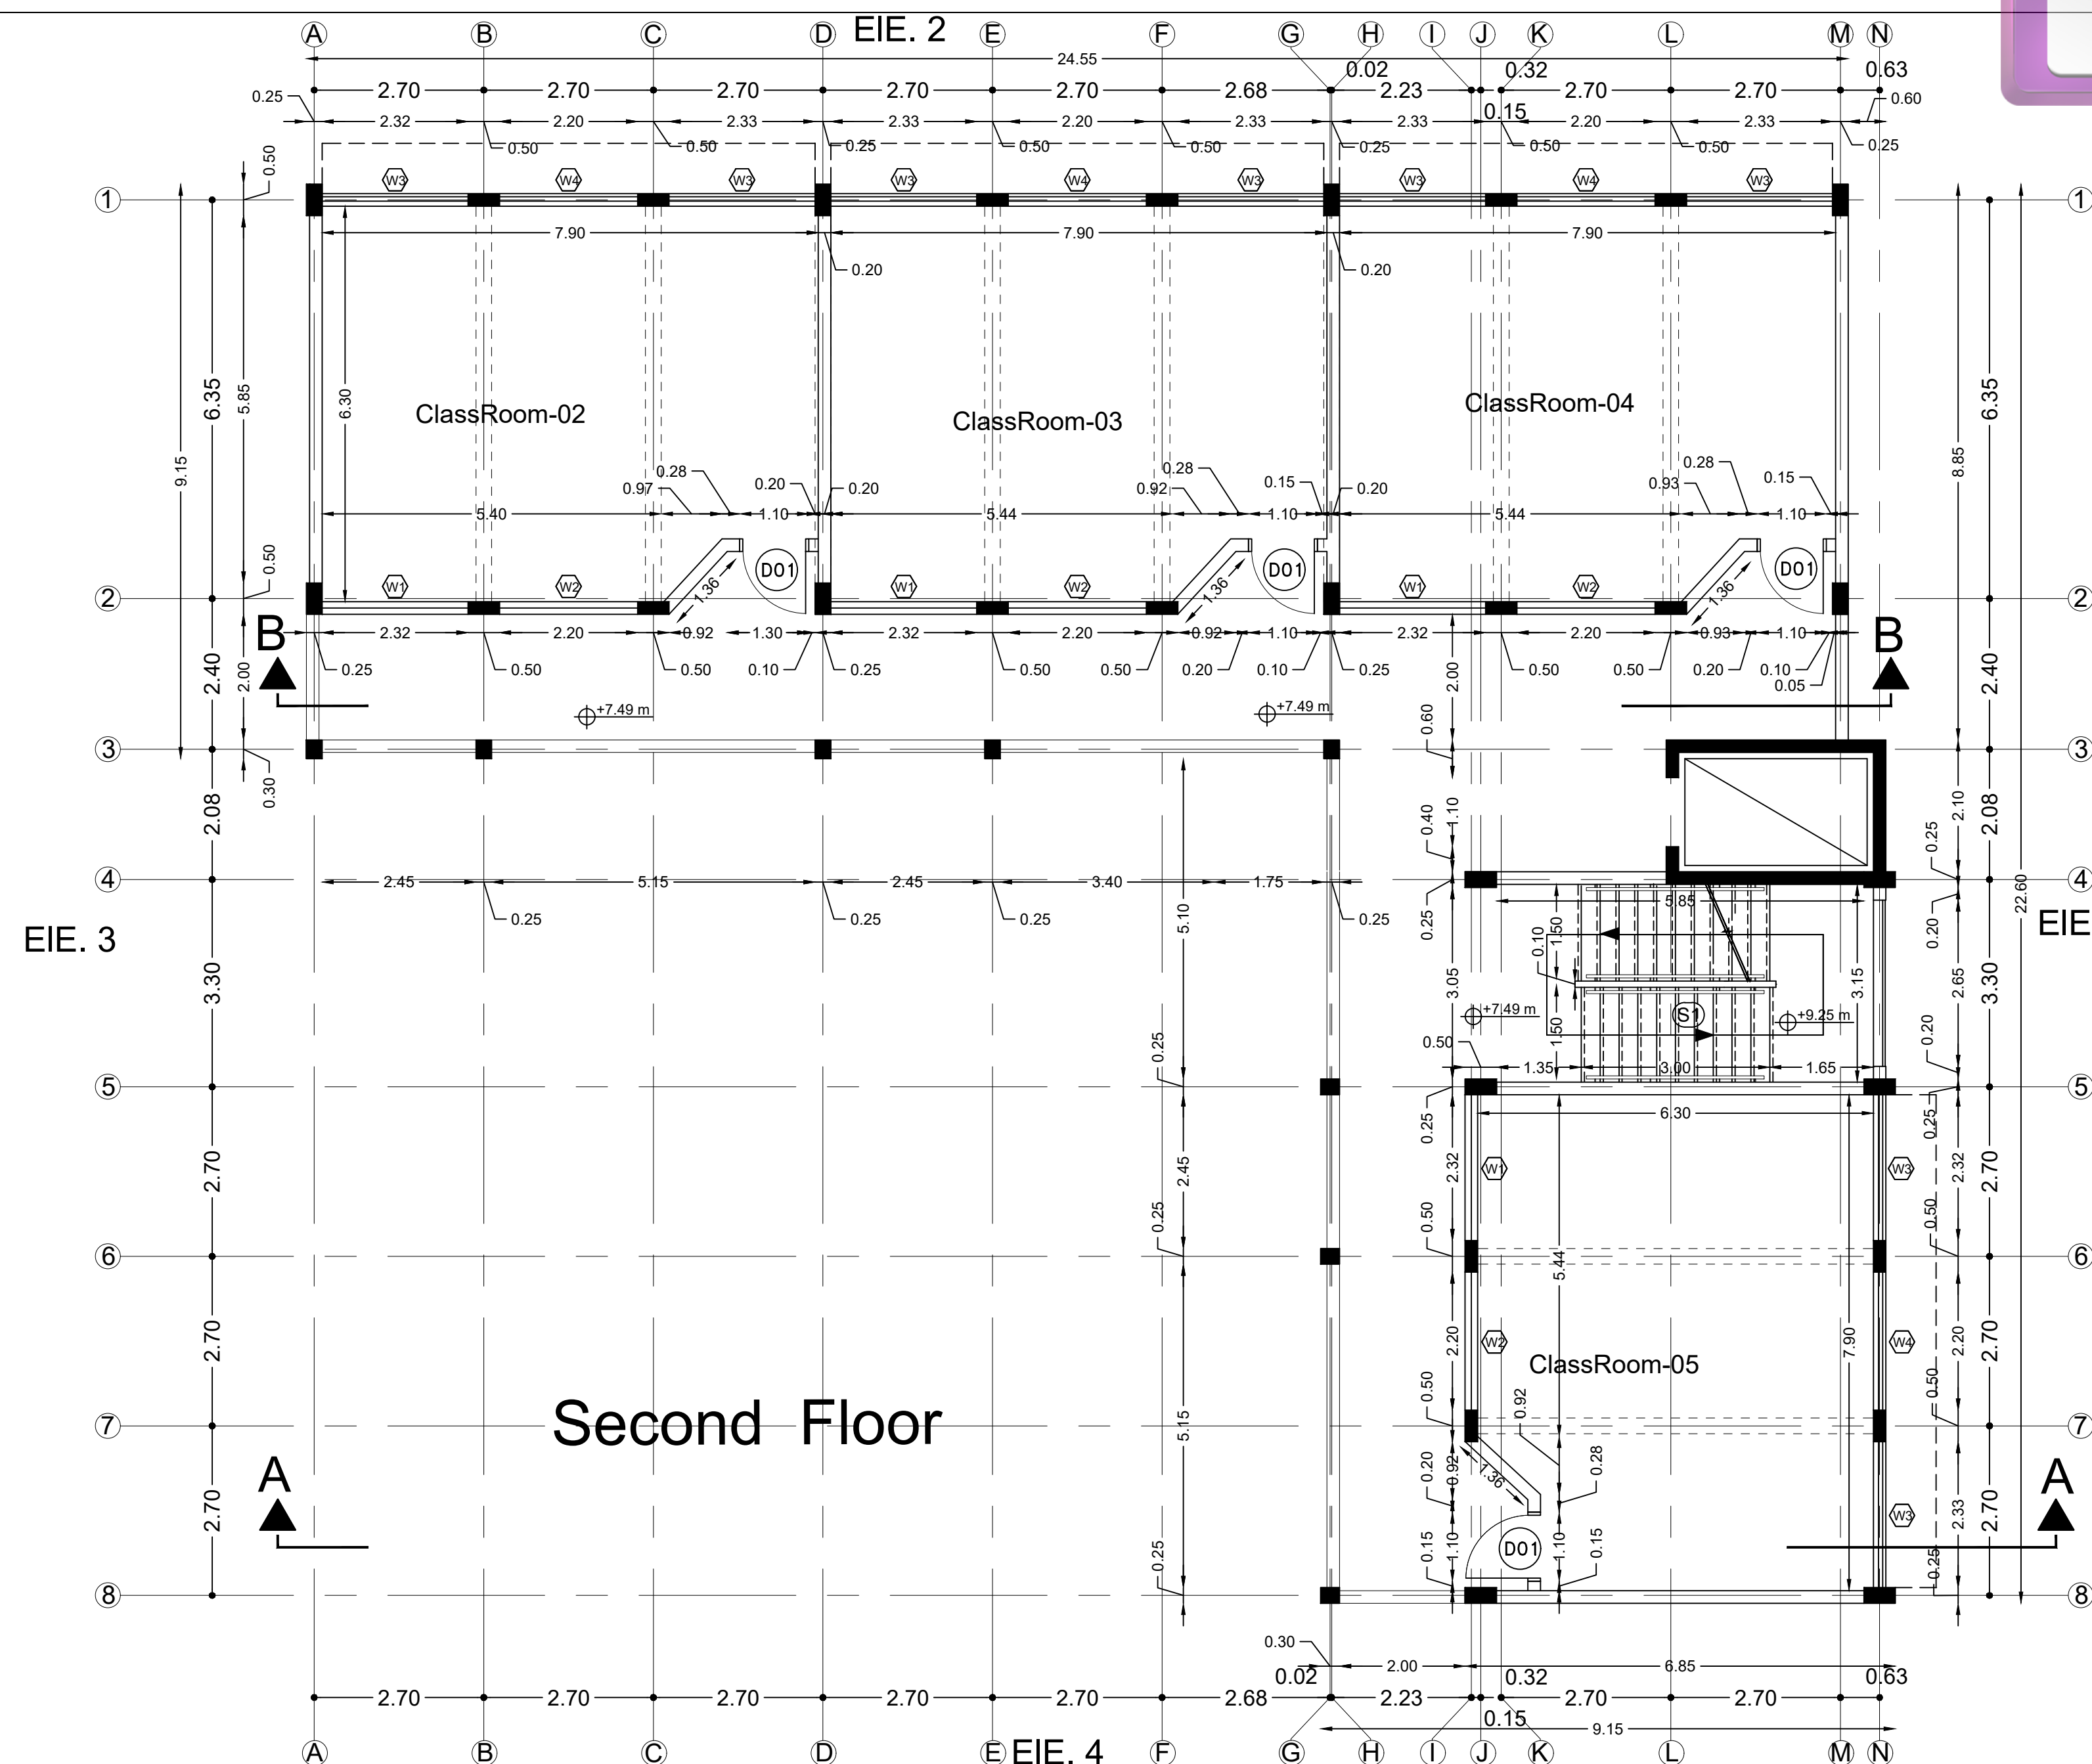



NOTES :-

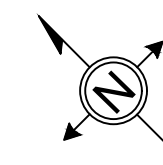

FUNDED BY:




EMPLEMENTED BY:



IN COOPERATION WITH:



CONSULTANT:

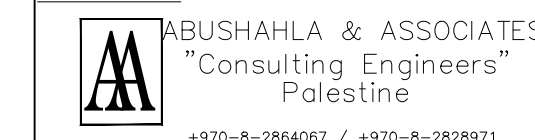

+970-8-2864067 / +970-8-2828971

Eshjaia School

DRAWING TITLE:

Eshjaia School

Proposed Third Floor

DESIGN: AA

DRAWN: AA


APPROVED: AA

SHEET NO:

A010

DATE: 20-February-2016

SCALE: 1:100

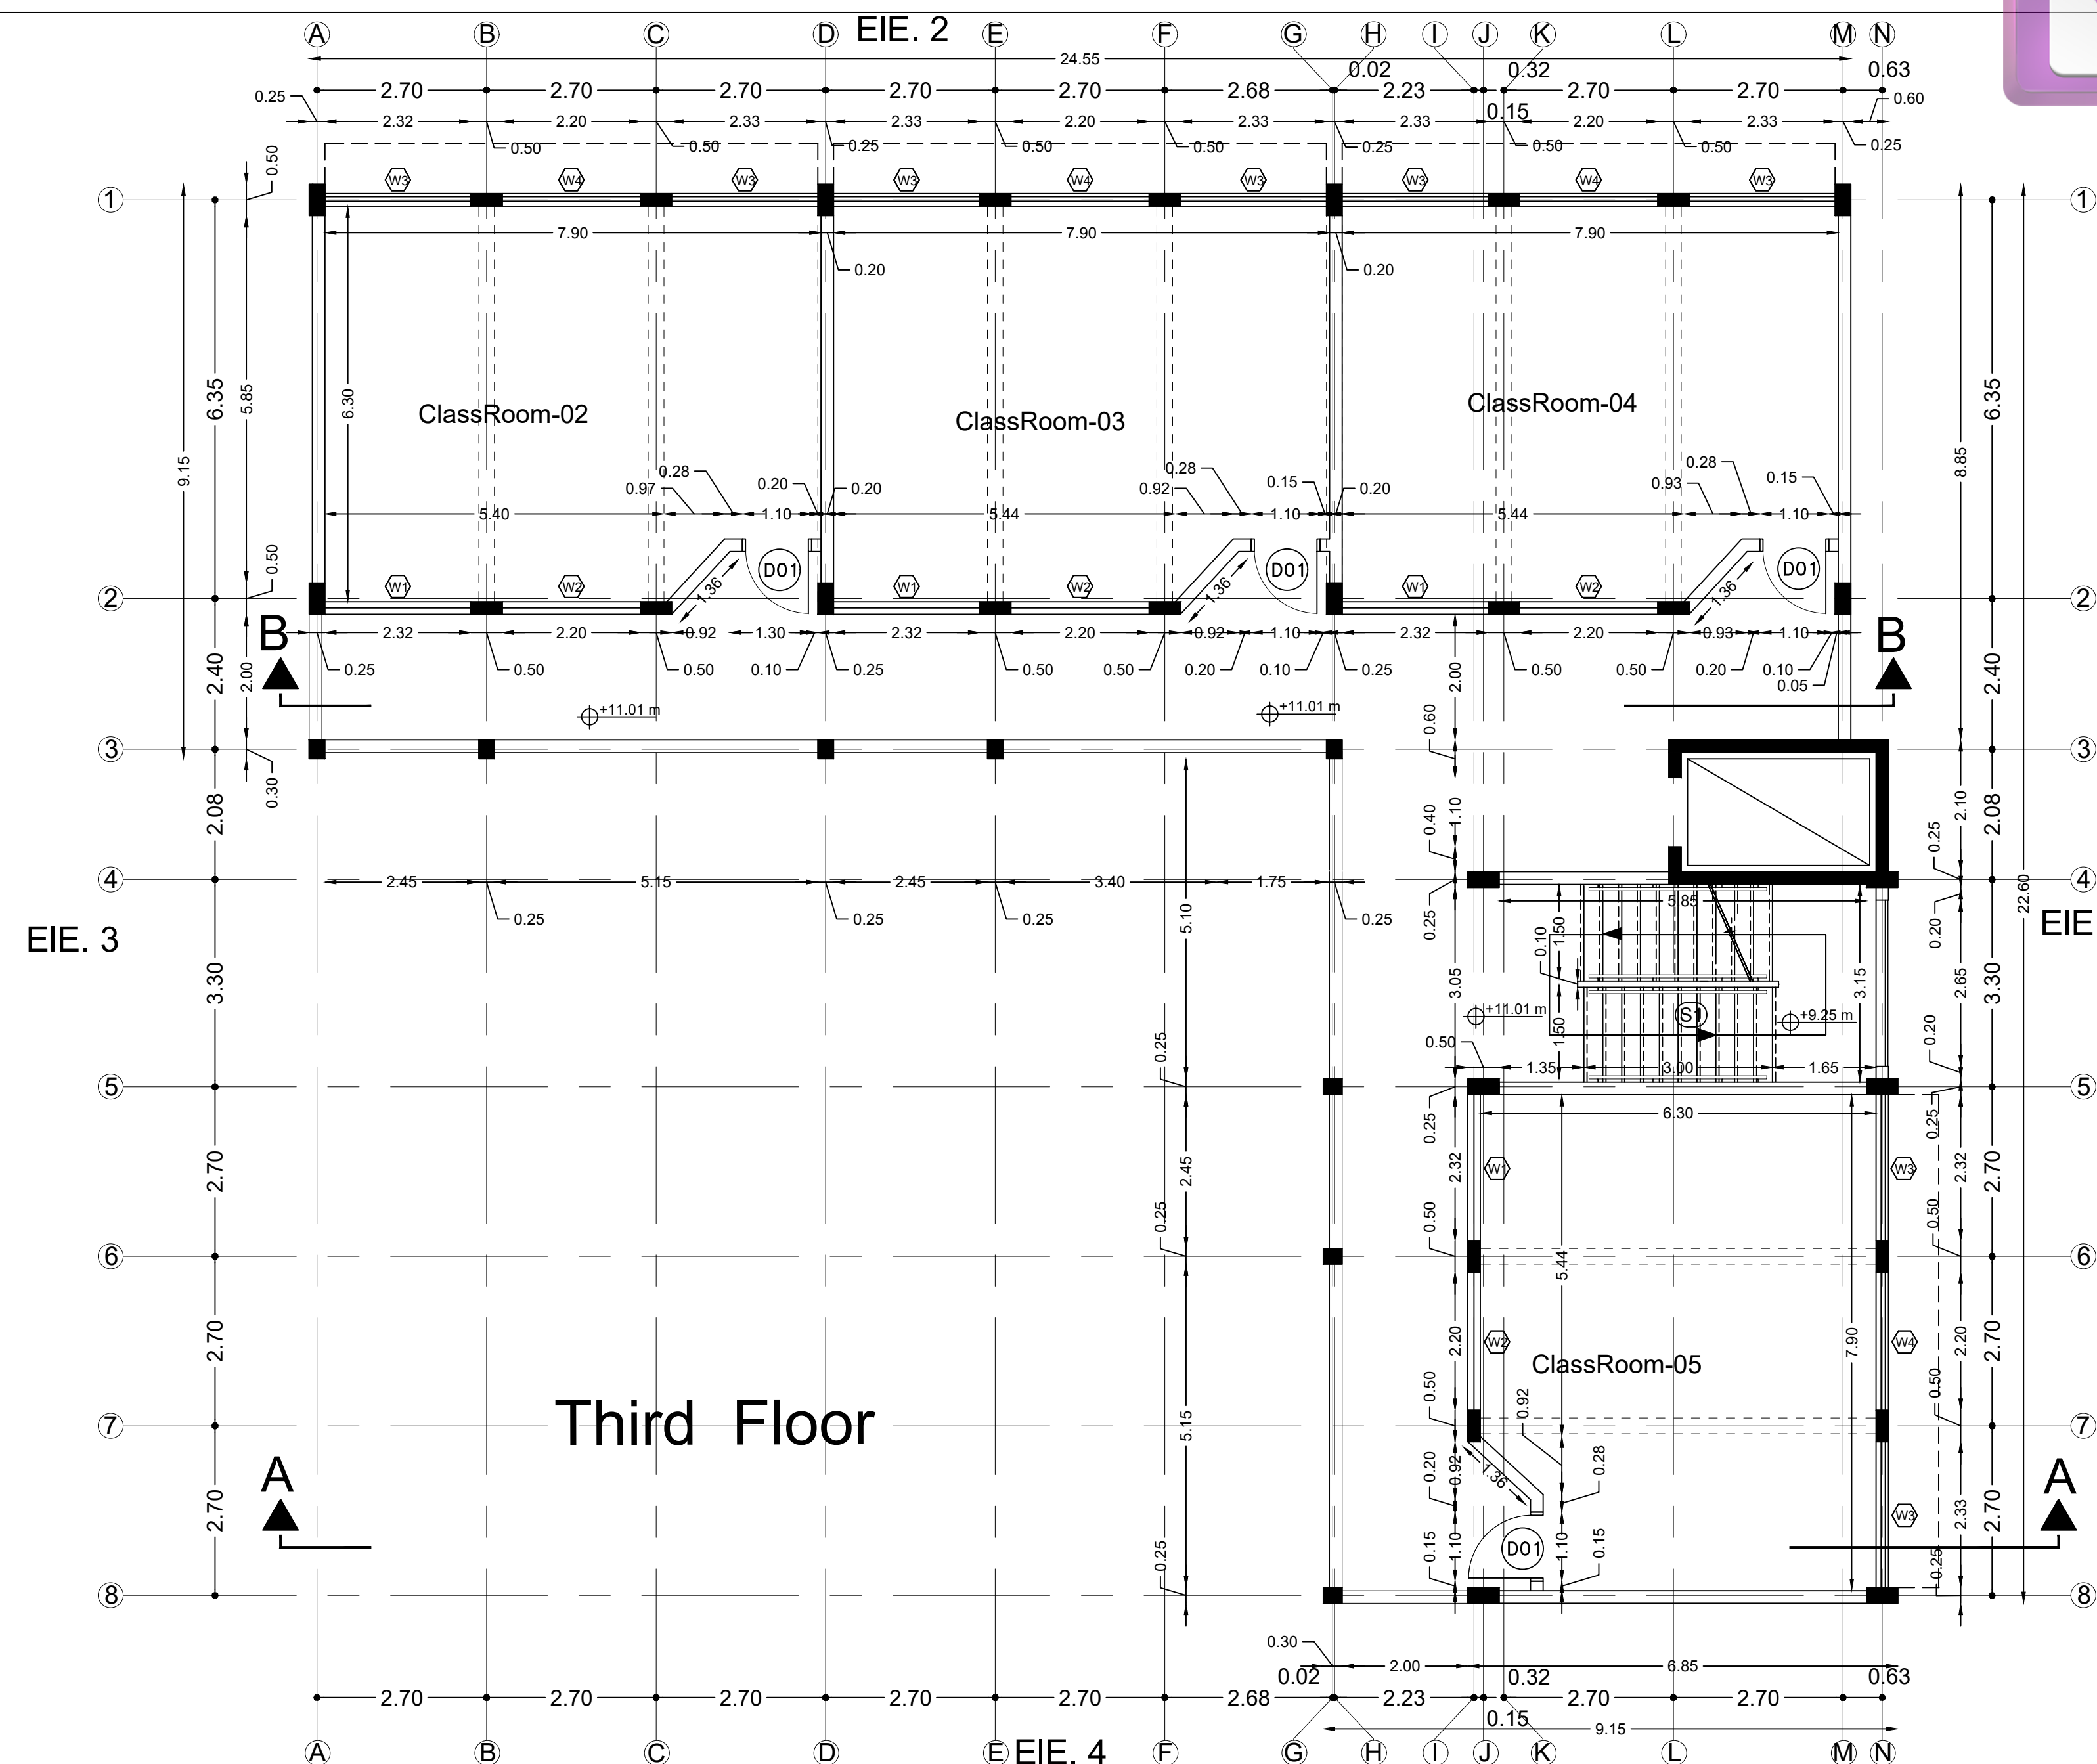



Edited with the trial version of
Foxit Advanced PDF Editor


To remove this notice, visit:

www.foxitsoftware.com/shopping



State of Palestine
Ministry of Education & Higher Education

NOTES :-

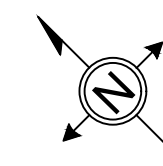

FUNDED BY:




EMPLEMENTED BY:




IN COOPERATION WITH:



CONSULTANT:

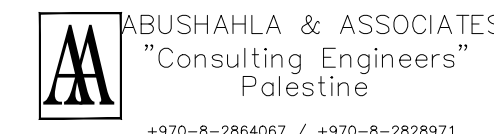


Eshjaia School	
DRAWING TITLE: Eshjaia School	
Proposed Roof Floor	
DESIGN: AA	DATE: 20-February-2016
DRAWN: AA	SCALE: 1:100
APPROVED: AA	
SHEET NO: A011	

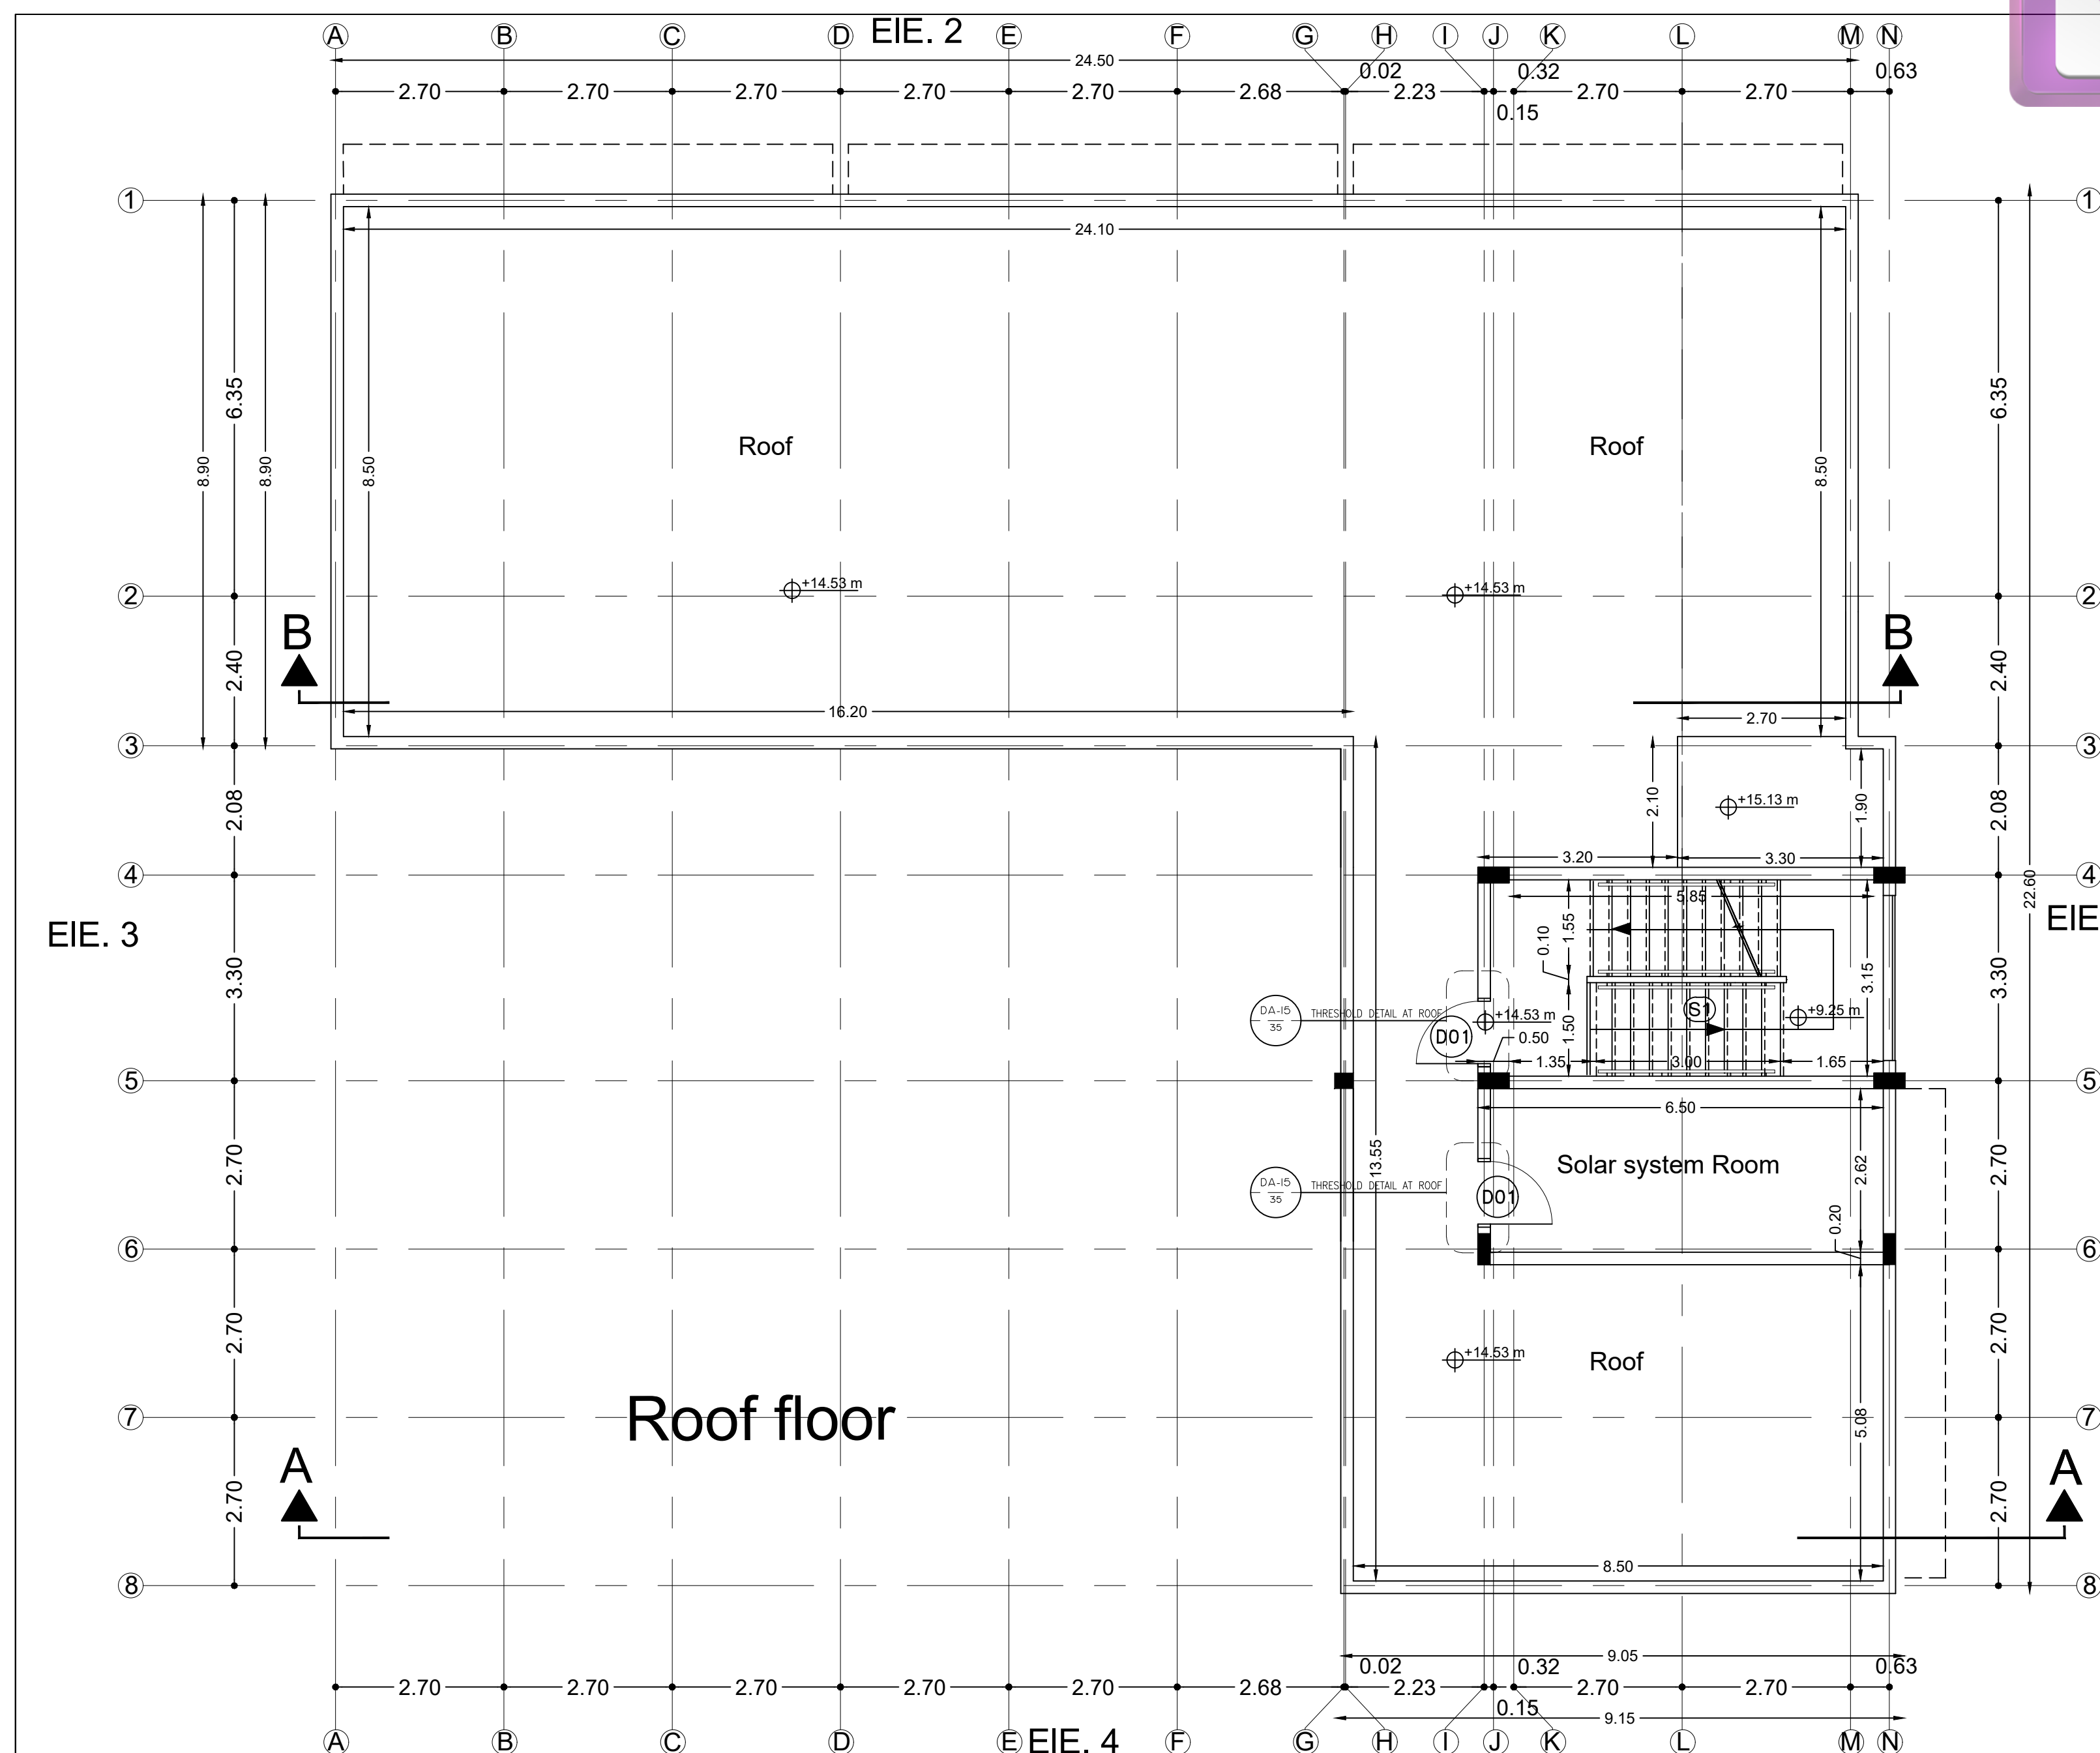



State of Palestine
Ministry of Education & Higher Education

NOTES :-

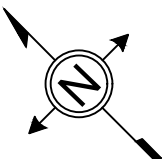

FUNDED BY:



EMPLEMENTED BY:



IN COOPERATION WITH:



CONSULTANT:



ABUSHAHLA & ASSOCIATES
"Consulting Engineers"
Palestine

+970-8-2864067 / +970-8-2828971

Eshjaia School

DRAWING TITLE:

Eshjaia School

Proposed top view

DESIGN: AA

DRAWN: AA


APPROVED: AA


SHEET NO:

A012

DATE: 20-February-2016

SCALE: 1:100

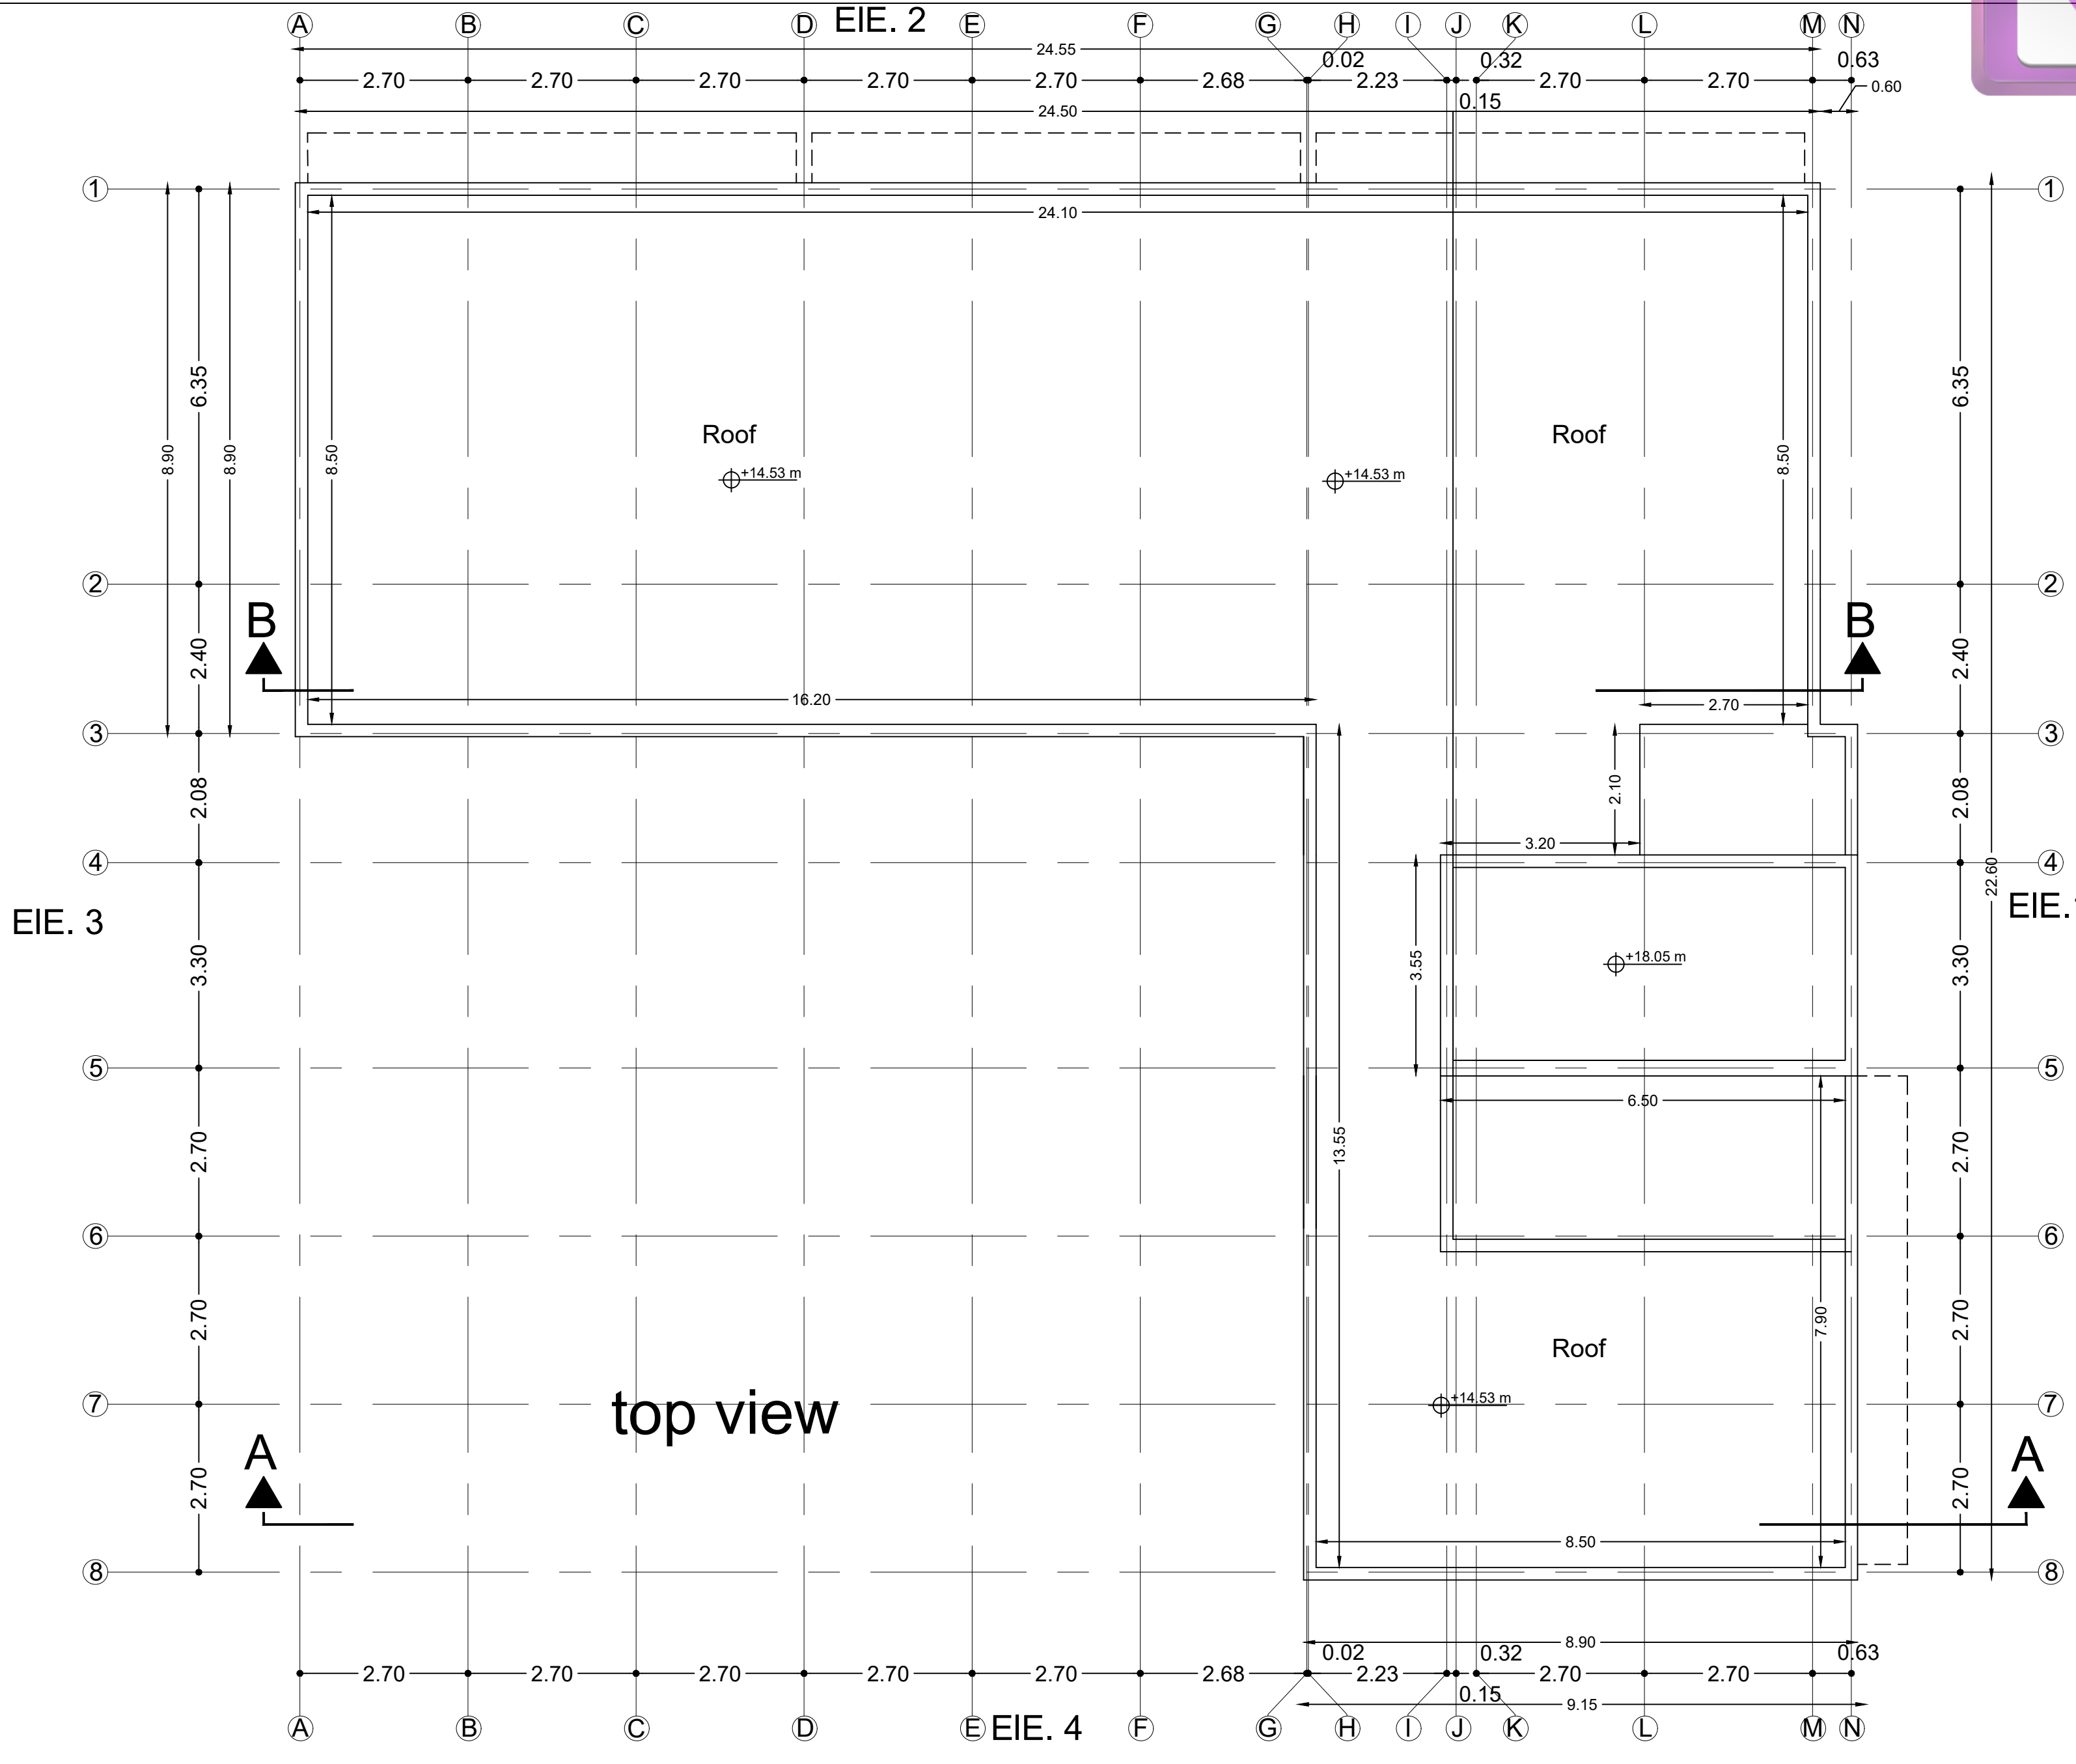

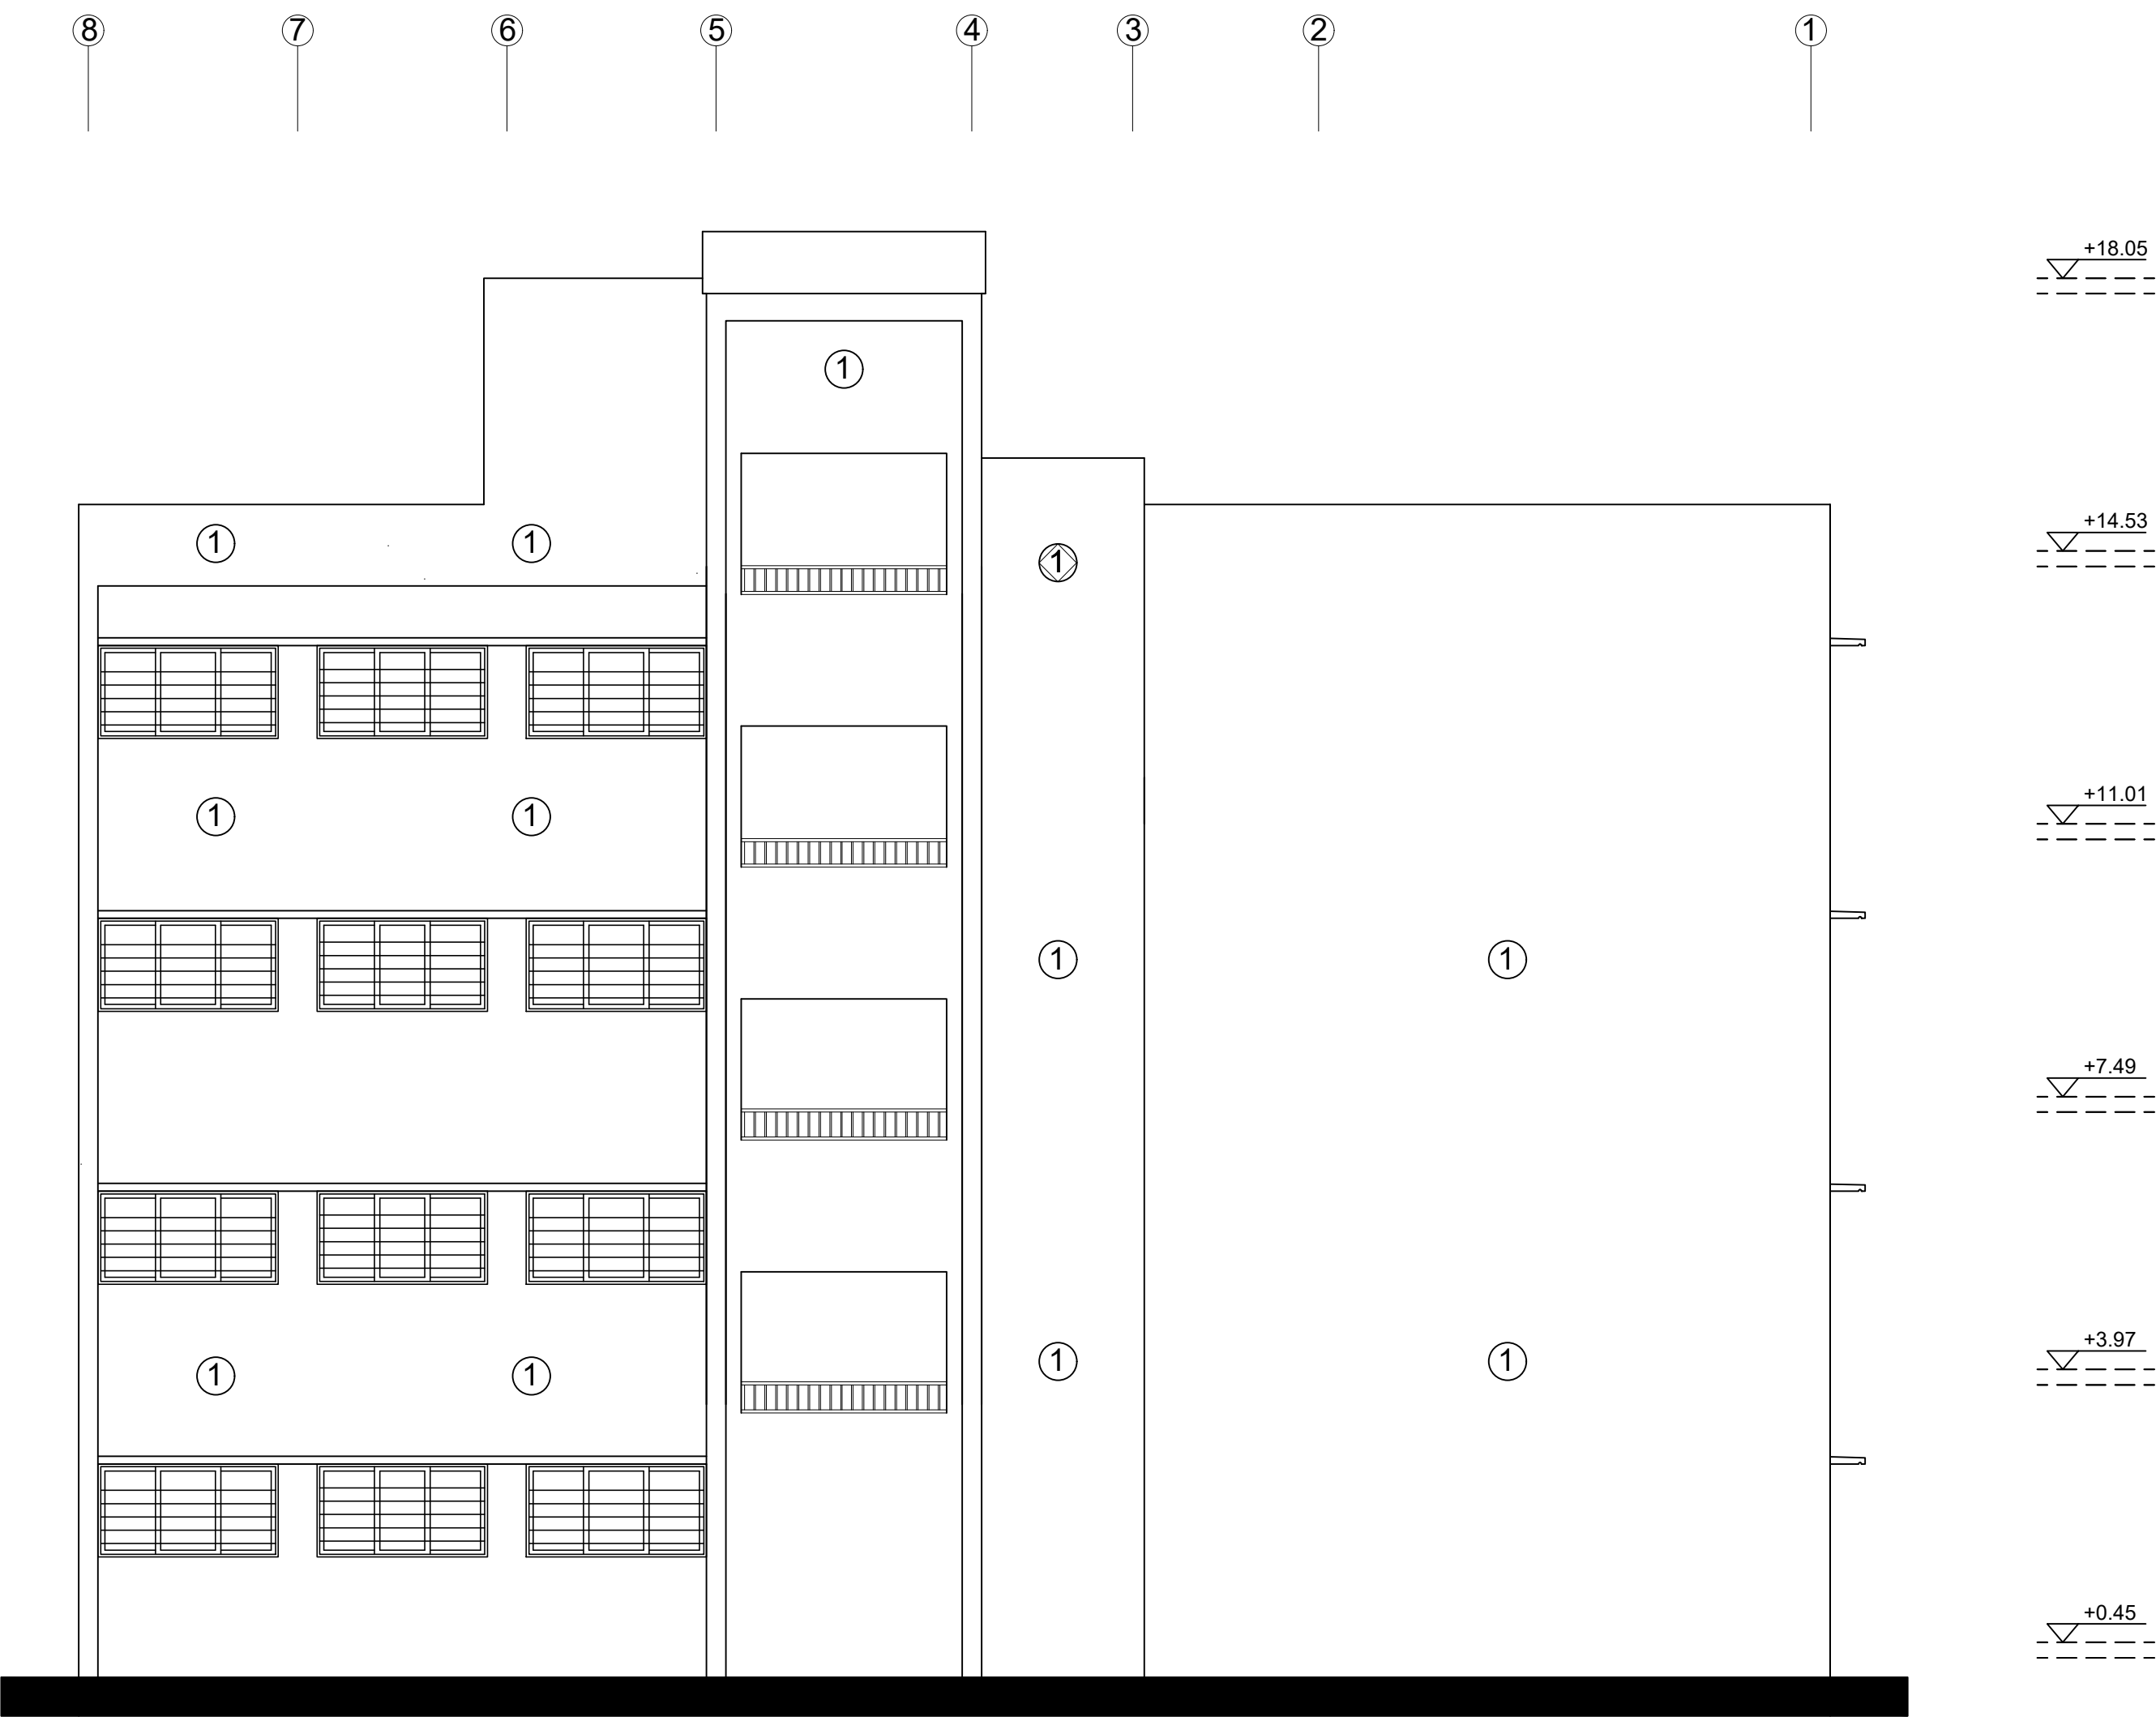

First Elevation

State of Palestine
Ministry of Education & Higher Education

NOTES :-

FUNDED BY:



EMPLEMENTED BY:



IN COOPERATION WITH:




CONSULTANT:



ABUSHAHLA & ASSOCIATES
"Consulting Engineers"
Palestine
+970-8-2864067 / +970-8-2828971

Eshijaia School	
DRAWING TITLE: Eshijaia School	
Proposed First Elevation	
DESIGN: AA	DATE: 20-February-2016
DRAWN: AA	SCALE: 1:100
APPROVED: AA	
SHEET NO: A013	

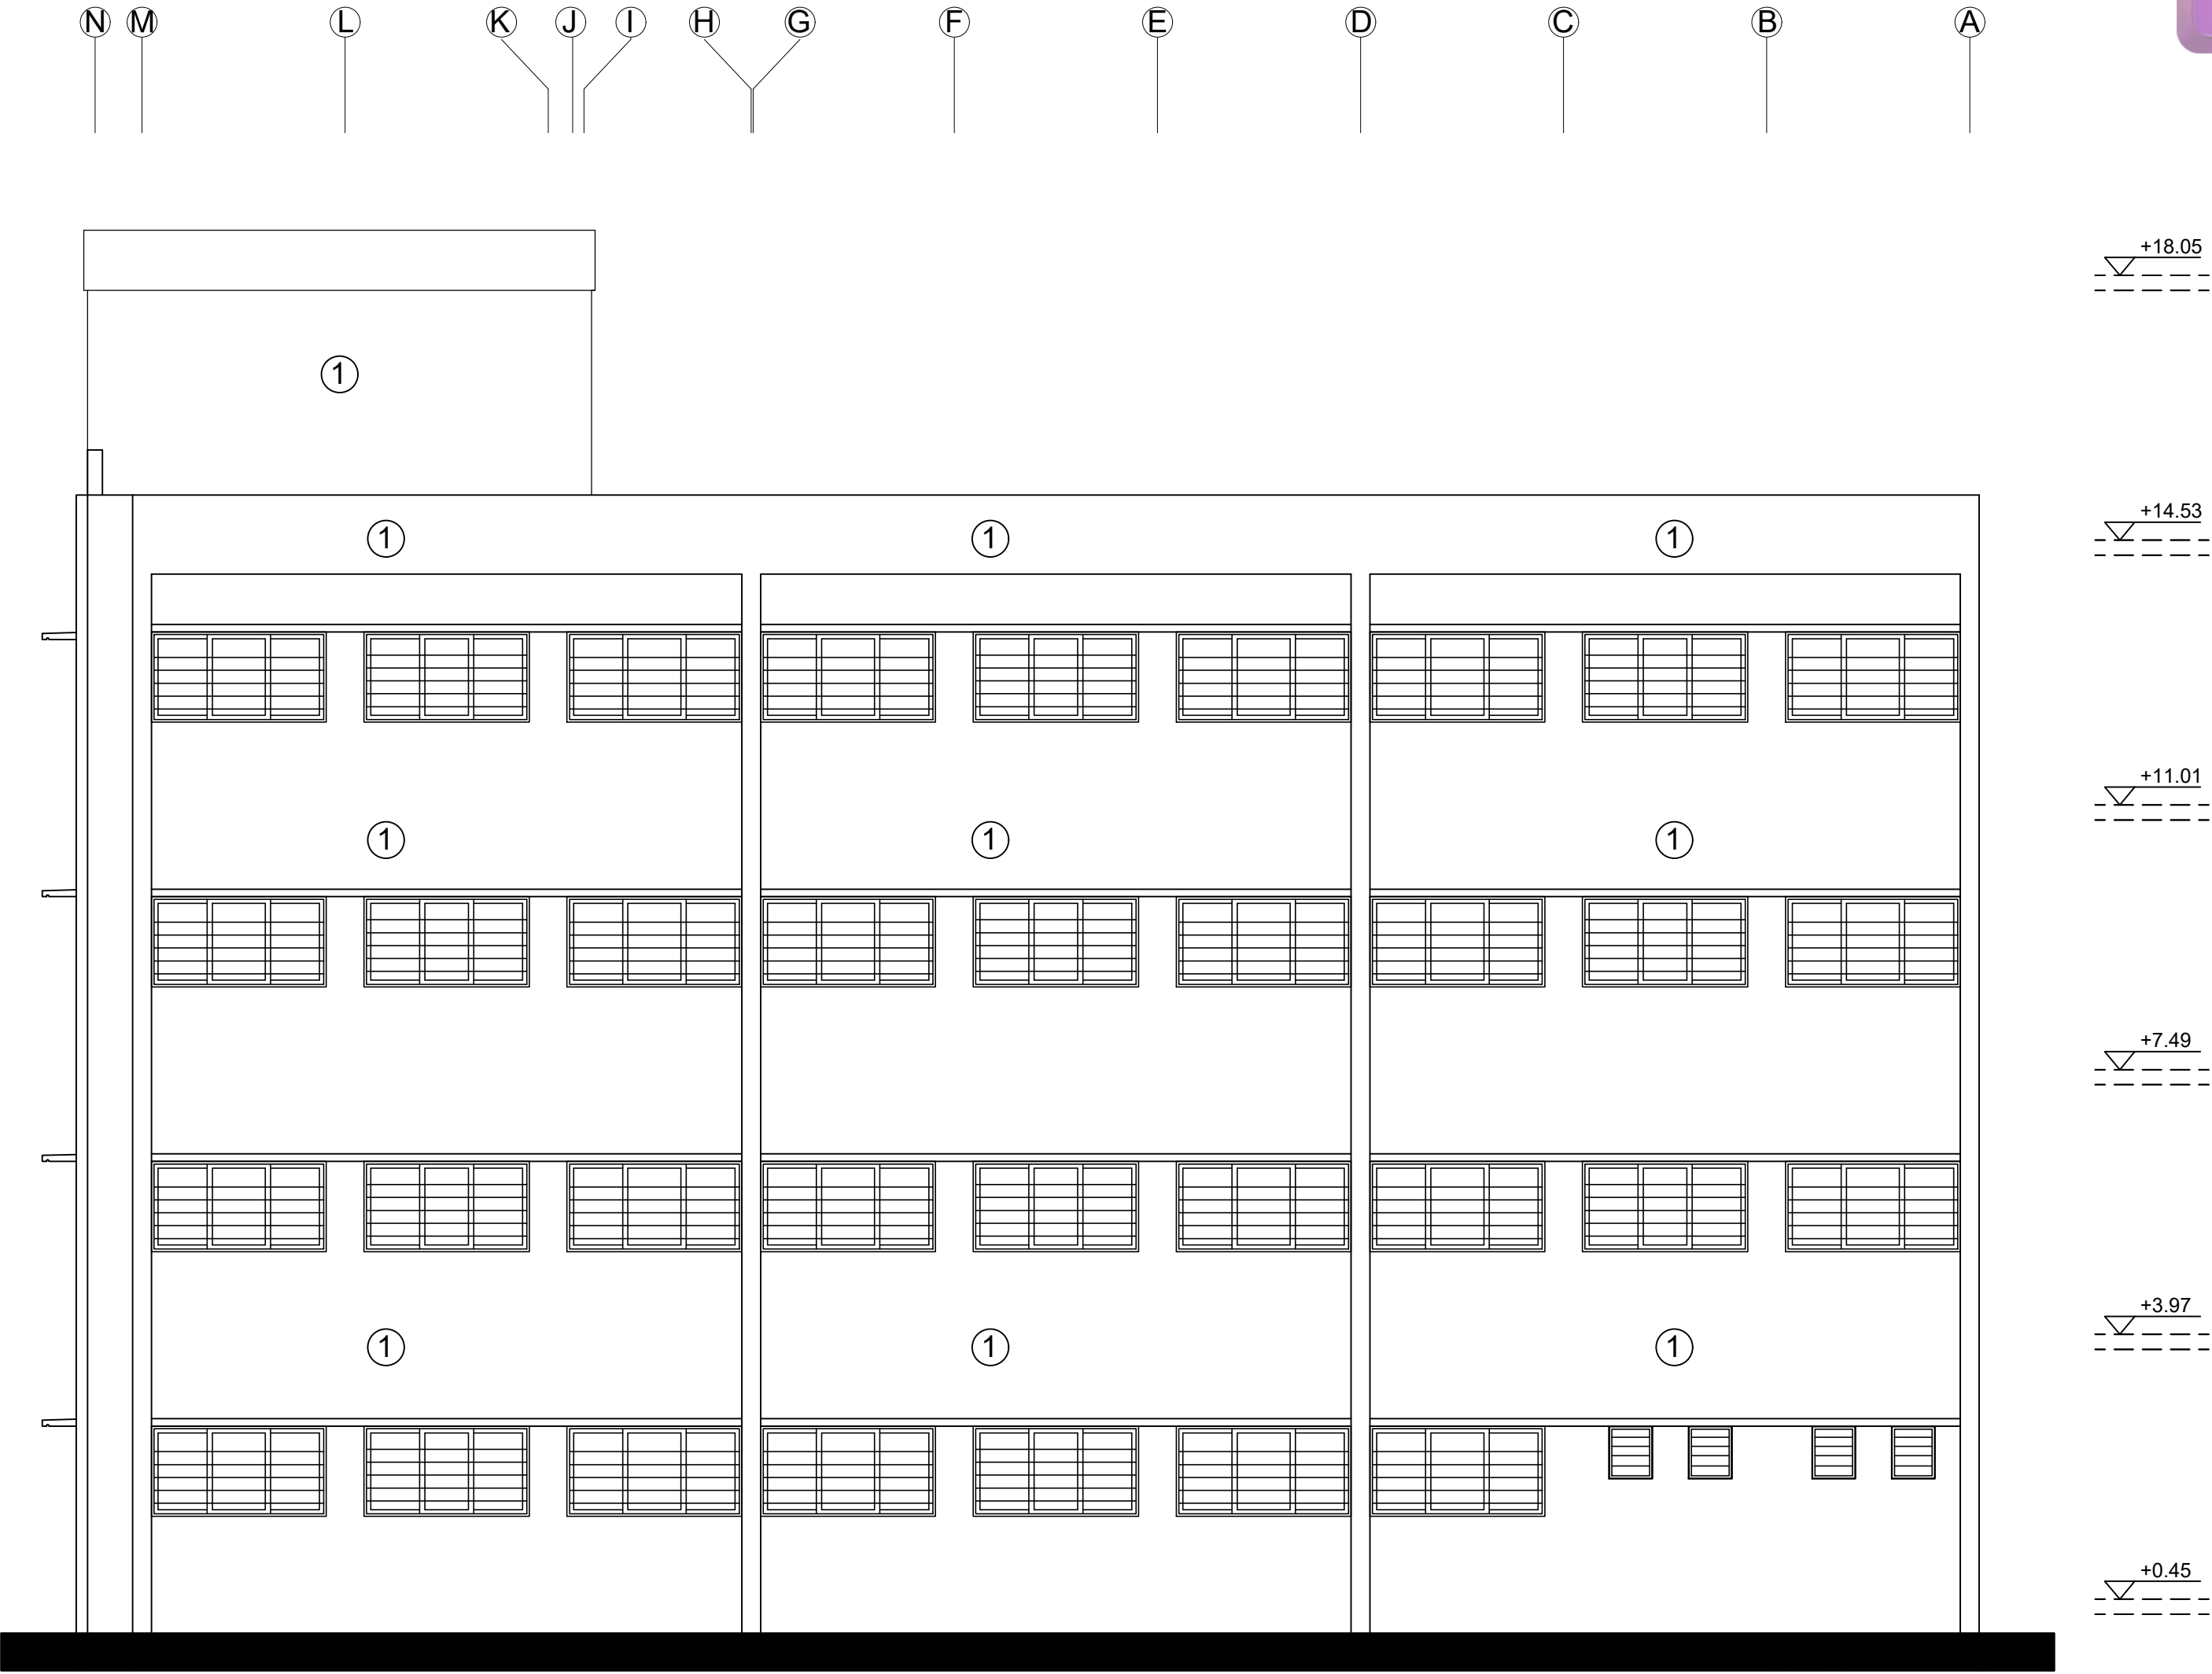

Second Elevation

State of Palestine
Ministry of Education & Higher Education

NOTES :-

FUNDED BY:



EMPLEMENTED BY:



Empowered lives, Resilient nation

IN COOPERATION WITH:



CONSULTANT:



ABUSHAHLA & ASSOCIATES
"Consulting Engineers"
Palestine

+970-8-2864067 / +970-8-2828971

Eshijaia School	
DRAWING TITLE: Eshijaia School	
Proposed Second Elevation	
DESIGN: AA	DATE: 20-February-2016
DRAWN: AA	SCALE: 1:100
APPROVED:AA	
SHEET NO: A014	