



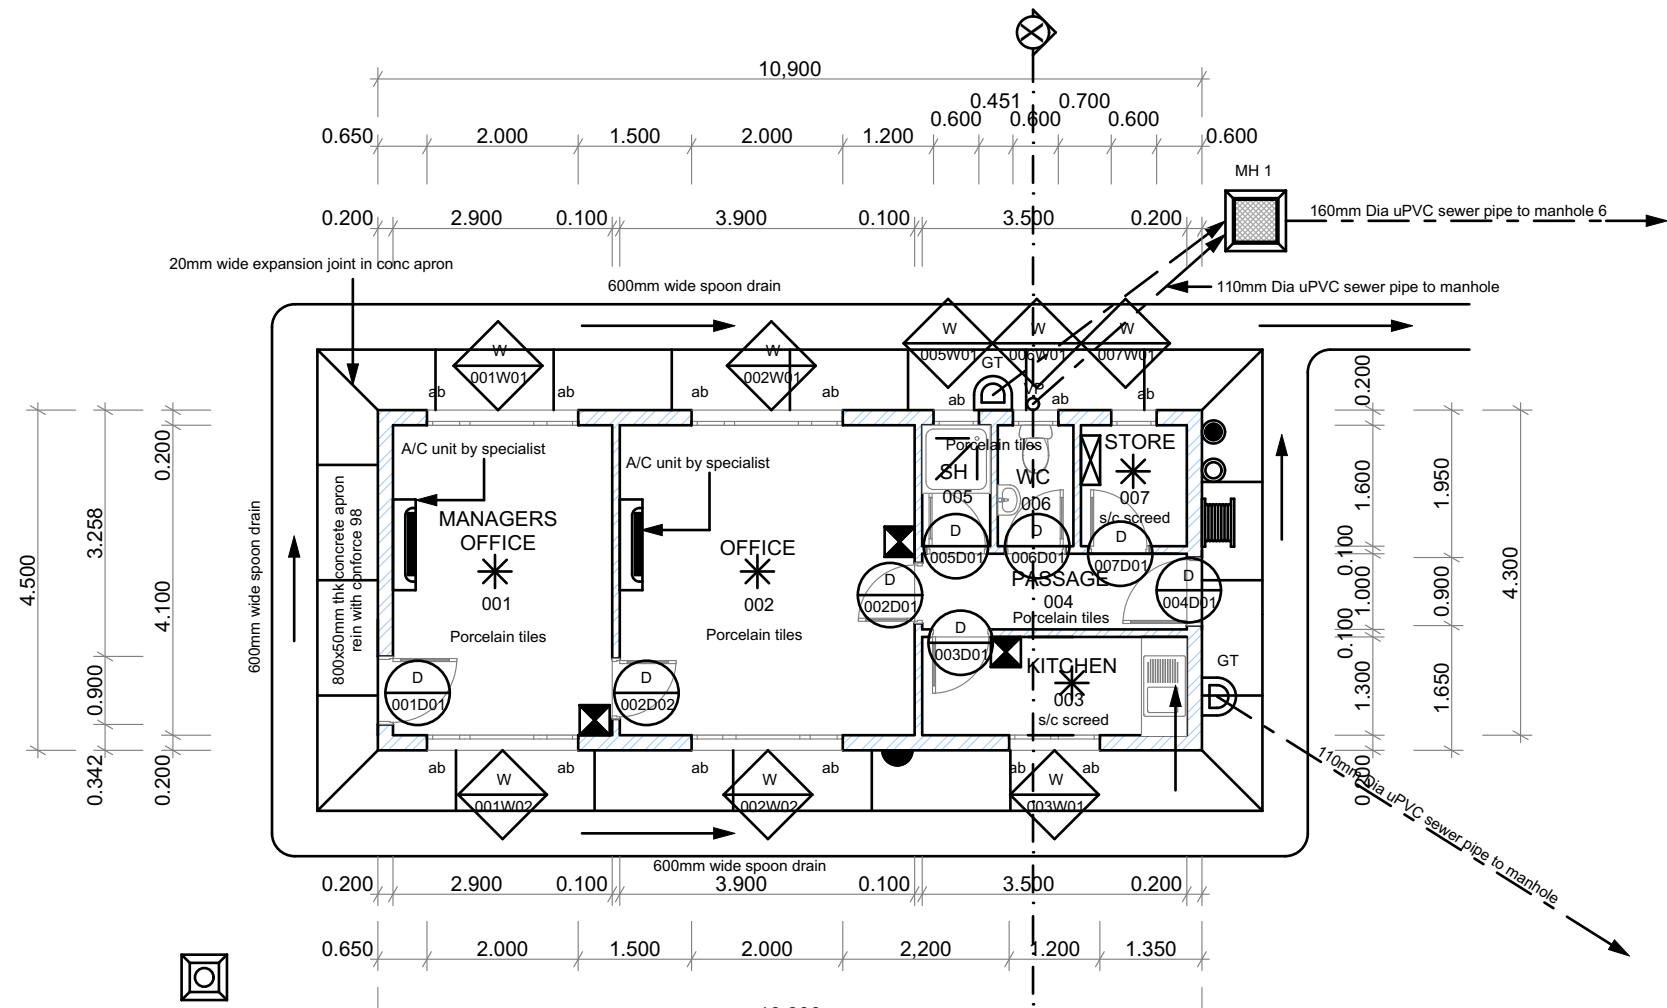


FLOOR PLAN


1:100

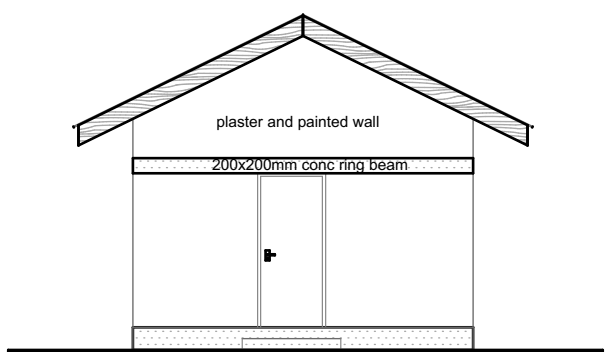


LEFT SIDE ELEVATION

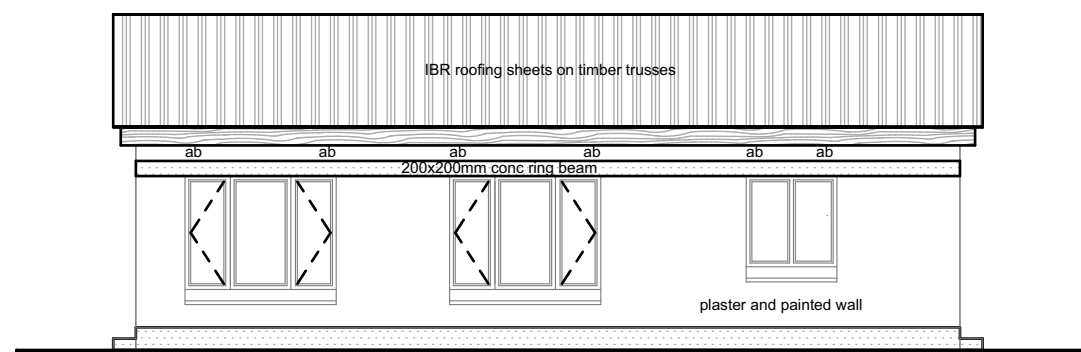


FRONT ELEVATION

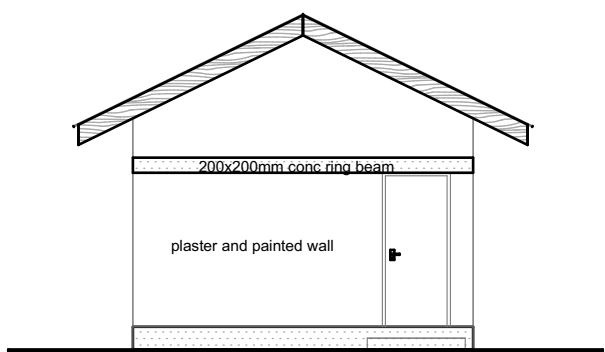

RIGHT SIDE ELEVATION

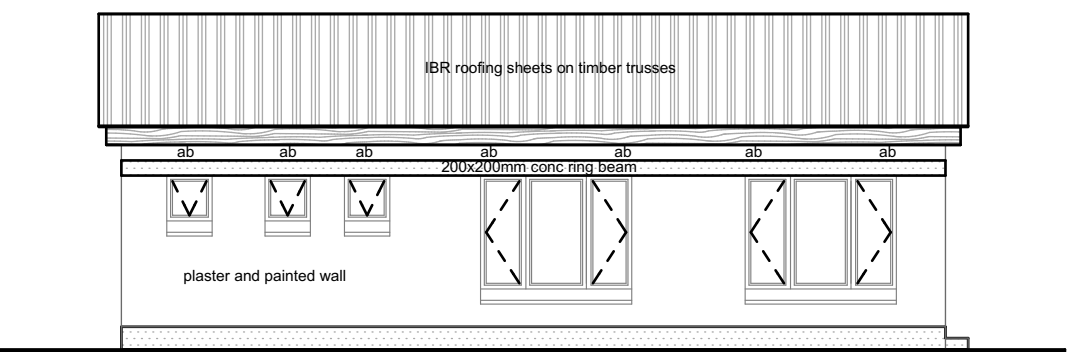


REAR ELEVATION

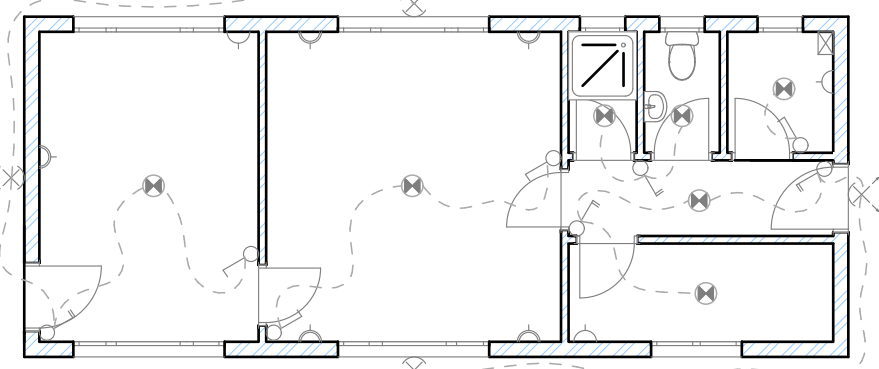


ELECTRICAL LAYOUT

1:100

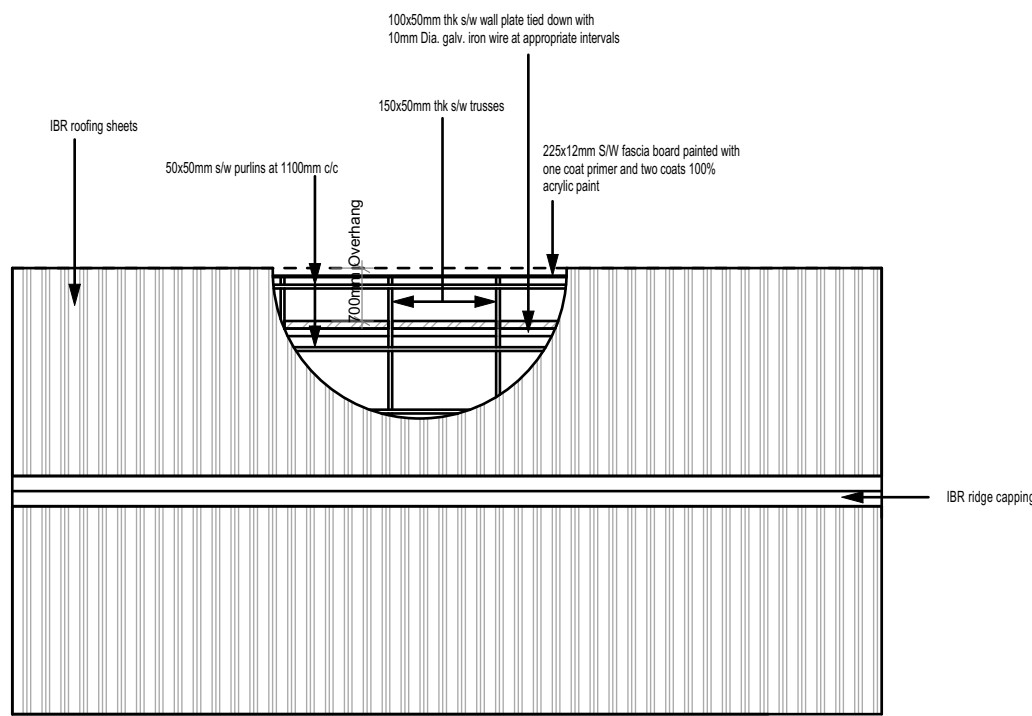

ROOF PLAN

1:100

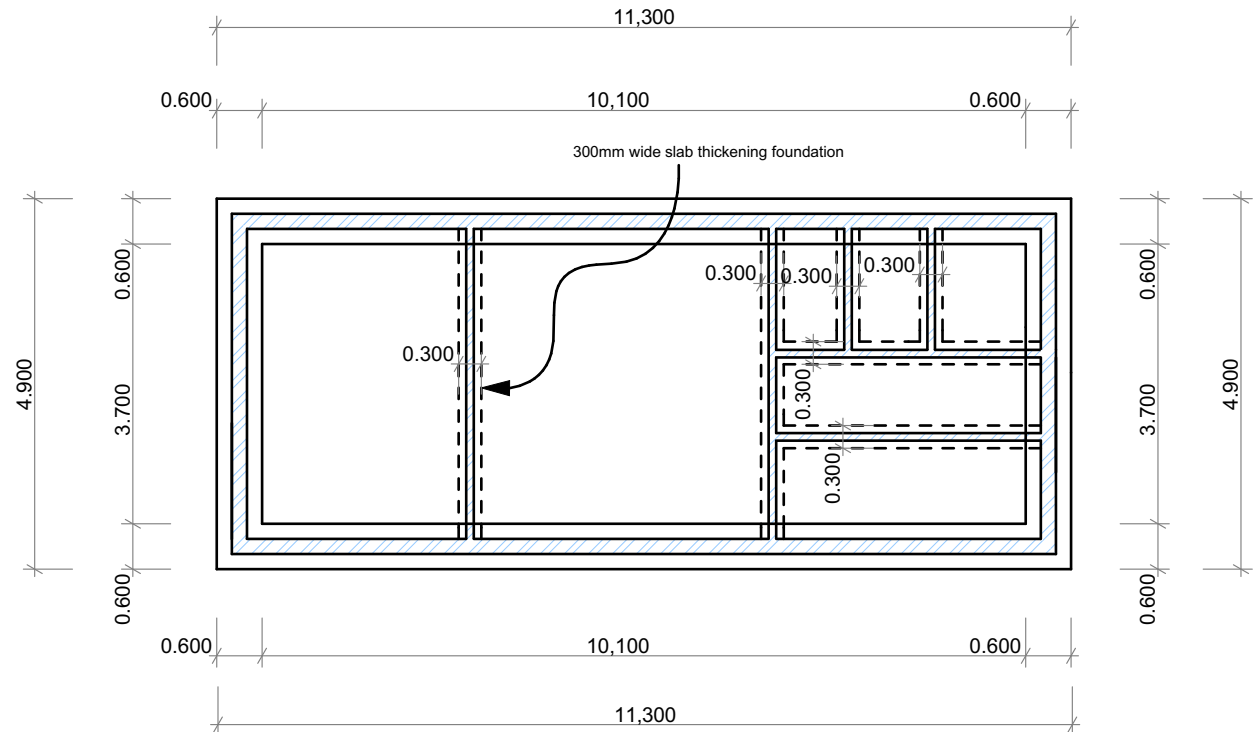

FOUNDATION PLAN

1:100


DOOR SCHEDULE

DOOR No	DOOR LOCATION	DOOR DESIGN	DOOR QUANTITY	SPECIFICATIONS
001D01 004D01 007D01	MANAGERS OFFICE PASSAGE STORE		03	DOOR SIZE - 2000 x 800mm DOOR FRAME - 200mm wide Pressed steel frame DOOR TYPE - Rosewood solid timber door DOOR FINISH - Painted DOOR PATTERN - Plain door DOOR HANDLE - Satin Chrome finished door handles DOOR HINGES - 4-2x38x150mm brushed brass butt hinges DOOR LOCK - 4 Lever LEGGE or UNION mortice lockset DOOR STOP - Floor mounted rubber door stoppers DOOR SWING - 260 Right DOOR CLOSER - Pneumatic door closer
002D01 002D02	OFFICE OFFICE		02	DOOR SIZE - 2200 x 800mm DOOR FRAME - 100mm wide Pressed steel frame DOOR TYPE - Rosewood laminated timber flush door DOOR FINISH - Painted DOOR PATTERN - Plain door DOOR HANDLE - Satin Chrome finished door handles DOOR HINGES - 4-2x38x150mm brushed brass butt hinges DOOR LOCK - 3 Lever LEGGE or UNION mortice lockset DOOR STOP - Floor mounted rubber door stoppers DOOR SWING - 260 Right DOOR CLOSER - Pneumatic door closer
003D01 005D01 006D01	STORE SHOWER TOILET		03	DOOR SIZE - 2000 x 800mm DOOR FRAME - 100mm wide Pressed steel frame DOOR TYPE - Rosewood laminated timber flush door DOOR FINISH - Painted DOOR PATTERN - Plain door DOOR HANDLE - Satin Chrome finished door handles DOOR HINGES - 4-2x38x150mm brushed brass butt hinges DOOR LOCK - 4 Lever LEGGE or UNION mortice lockset DOOR STOP - Floor mounted rubber door stoppers DOOR SWING - 260 Left and 260 Right DOOR CLOSER - Nil

1:100

WINDOW SCHEDULE

WINDOW No	WINDOW LOCATION	WINDOW DESIGN	WINDOW QUANTITY	SPECIFICATIONS
001W01 001W02 002W01 002W02	MANAGERS OFFICE MANAGERS OFFICE OFFICE OFFICE		04	WINDOW SIZE - 2000 x 1300mm WINDOW FRAME - Anodised Aluminium window frame WINDOW TYPE - Anodised Aluminium window WINDOW FINISH - Bronze WINDOW HANDLE - Satin Chrome finished Union handles WINDOW HINGES - 4-2x38x150mm Aluminium Hinges WINDOW GLAZING - 6mm thick Laminated clear float glass WINDOW SASH - Double wing BURGLAR PROOFING - 900 steel burglar bars
003W01	KITCHEN		01	WINDOW SIZE - 1200 x 1200mm WINDOW FRAME - Anodised Aluminium window frame WINDOW TYPE - Anodised Aluminium window WINDOW FINISH - Bronze WINDOW HANDLE - Satin Chrome finished Union handles WINDOW HINGES - 4-2x38x150mm Aluminium Hinges WINDOW GLAZING - 6mm thick Laminated clear float glass WINDOW SASH - Double wing BURGLAR PROOFING - 900 steel burglar bars
005W01 006W02 007W01	SHOWER TOILET STORE		03	WINDOW SIZE - 600 x 600mm WINDOW FRAME - Anodised Aluminium window frame WINDOW TYPE - Anodised Aluminium window WINDOW FINISH - Bronze WINDOW HANDLE - Satin Chrome finished Union handles WINDOW HINGES - 4-2x38x150mm Aluminium Hinges WINDOW GLAZING - 6mm thick Laminated clear float glass WINDOW SASH - Fly up BURGLAR PROOFING - 900 steel burglar bars

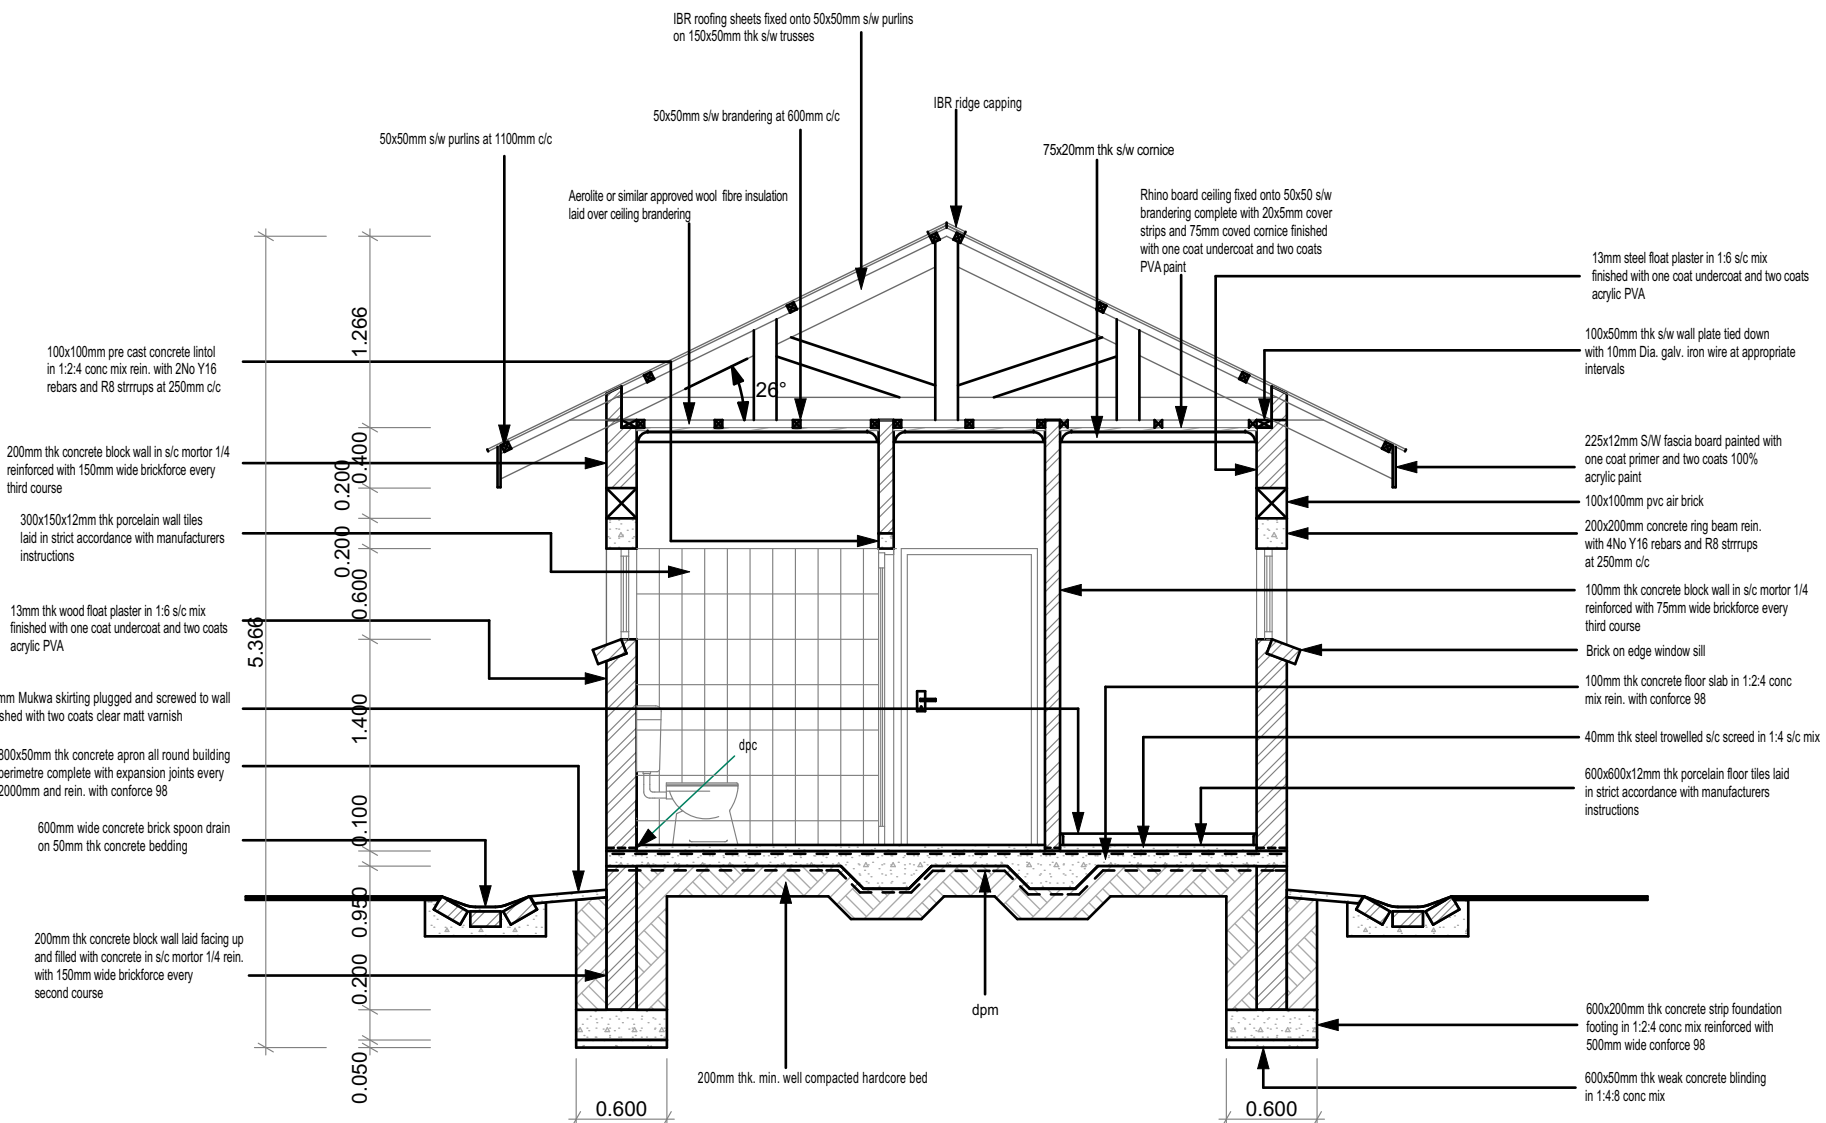

SECTION X - X

1:50

ELECTRICAL LEGEND		
	Single socket outlet 450mm above FFL	
	Double socket outlet 450mm above FFL	
	A/C single socket outlet 1850mm above FFL	
	Distribution board 1800mm above FFL	
	Pendant light fitting at ceiling level	
	Security light fitting 2300mm above FFL	
	One gang switch at 1500mm above FFL	
	Two gang switch at 1500mm above FFL	
	Conduit	

FIRE FIGHTING LEGEND		
	Dry chemical powder fire extinguisher	
	Carbon monoxide fire extinguisher	
	50mm Long fire hose reel	
	Fire hydrant	
	Fire sounder	
	Smoke detector	
	Fire alarm panel	
	Break glass	

Rev.No	Description	

Professor Albert Malama
LUSAKA
6th Floor Godfrey House,
Kabelanga Road,
P.O Box 33976,
Lusaka.
Tel: +260211238150| Fax: +260 211238102
KITWE
2nd Floor, Suite 330
Mukuba Pensions House
Cnr President Ave & Katanta St.
P. O. Box 21144
Tel +260-212-222302

Project
PROPOSED INCINERATOR FOR UNDP
Client
UNDP LUSAKA ZAMBIA

Drawing
OFFICE BLOCK-DOOR/WINDOW
SCHEDULE,ELEVATIONS,SECTION,
FLOOR,FOUNDATION,ROOF AND
ELECTRICAL PLANS

Purpose
FOR APPROVAL
Scale:1:100,50 Date: MAY 2016
Drawn by: T.M.
Checked By: KK
Project No:
Drawing No: