



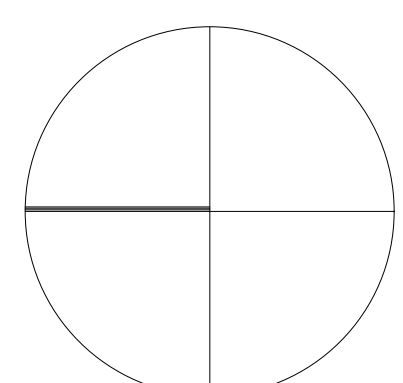

NOTES & LEGEND:

- WALL MOUNTED PARCEL UNIT
- CEILING SUPPLY GRILL (WITH DAMPER)
- RETURN GRILL
- EXHAUST SQUARE CEILING GRILL
- ROOM THERMOSTAT
- SAD SUPPLY AIR DUCT
- EXD EXHAUST AIR DUCT
- CENTRIFUGAL EXHAUST FAN
- IN-LINE EXTRACT FAN
- AXIAL EXTRACT FAN
- FLOW PIPE
- RETURN PIPE
- UNDERGROUND
- UNDERFLOOR
- AFD ABOVE FALSE CEILING
- F/A FROM ABOVE
- T/A TO ABOVE
- F/B FROM BELOW
- T/B TO BELOW

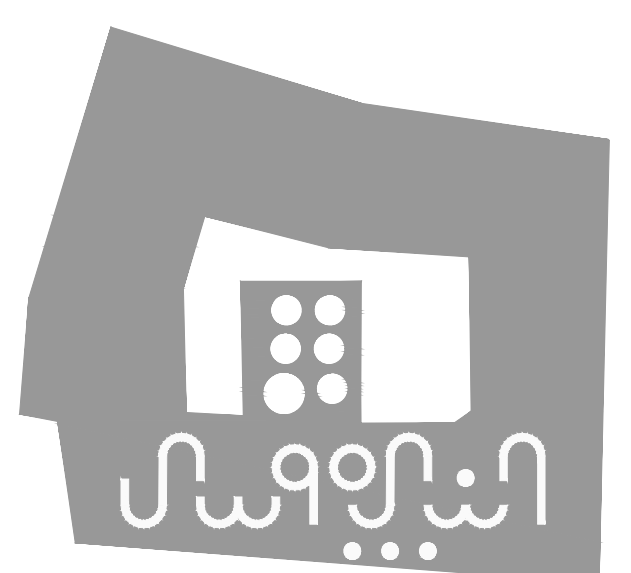

PROJECT:
Securing Professional Services for the Architectural Restoration and Rehabilitation Designs, Archaeological Documentation and Orientation Training, Including Tender Documents Preparation and Site Supervision for Conservation and Rehabilitation Works of Maqam Al-Nabi Musa in Jericho Governorate
Support to Development of Cultural Tourism

DESIGN WORKS:
jdc -Jerusalem Design Center

ELECTRICAL WORKS:
-Eng. Midhat AlSharif


MECHANICAL WORKS:
elite -Elite Mechanical Consultants

SHEET NAME:
**UNDERGROUND FLOOR
AC&VENTILATION PLAN**

SCALE: 1:100 (IF PILOTED ON A3)	EDITION: MECHANICAL
☐ For Review	SHEET NO. M400
☐ For Approval	
☒ For Tender	
☐ For Construction	DATE: July-2016

NOTES & LEGEND:

- WELL MOUNTED FAN/CEILING UNIT
- CEILING SUPPLY GRILL (WITH DAMPER)
- RETURN GRILL
- EXHAUST SQUARE CEILING GRILL
- ROOM THERMOSTAT
- SUPPLY AIR DUCT
- EXHAUST AIR DUCT
- CENTRIFUGAL EXHAUST FAN
- IN-LINE EXTRACT FAN
- AXIAL EXTRACT FAN
- FLOW PIPE
- RETURN PIPE
- UNDERGROUND
- UNDERTILE
- ABOVE FALSE CEILING
- FROM ABOVE
- TO ABOVE
- FROM BELOW
- TO BELOW

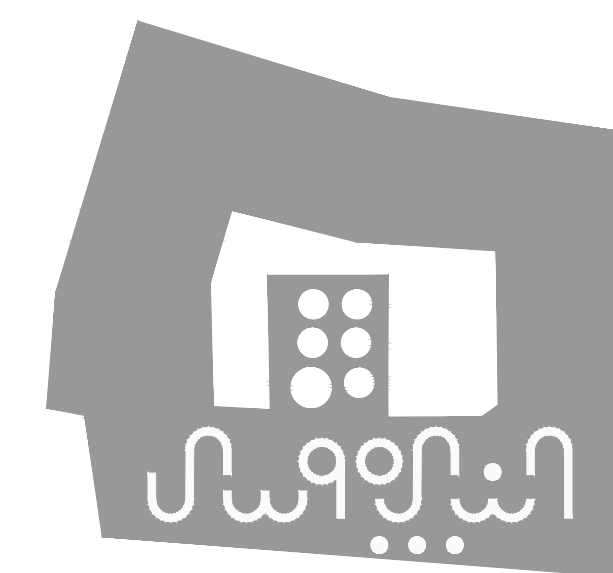

PROJECT:

Securing Professional Services for the Architectural Restoration and Rehabilitation Designs, Archaeological Documentation and Orientation Training, Including Tender Documents Preparation and Site Supervision for Conservation and Rehabilitation Works of Maqam Al-Nabi Musa in Jericho Governorate

Support to Development of Cultural Tourism

DESIGN WORKS:

Jerusalem Design Center

ELECTRICAL WORKS:

-Eng. Midhat AlSharif

MECHANICAL WORKS:

-Elite Mechanical Consultants

SHEET NAME:

GROUND FLOOR AC&VENTILATION PLAN

SCALE: 1:100

EDITION: 1

FOR APPROVAL

FOR TENDER


DATE: July-2016

DATE: July-2016




Phone: 02 234 3096 | Fax: 02 234 3719 | Email: info@jdc.ps



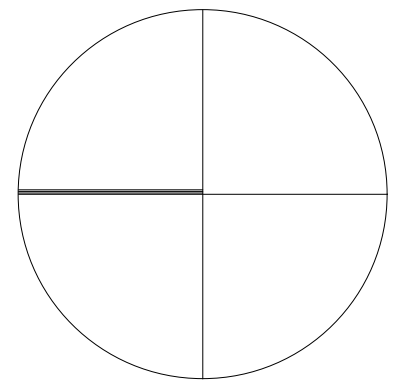

NOTES & LEGEND:

- WALL MOUNTED FRIGIDOL UNIT
- CEILING SUPPLY GRILL (WITH DAMPER)
- RETURN GRILL
- EXHAUST SQUARE CEILING GRILL
- ROOM THERMOSTAT
- SAG SUPPLY AIR DUCT
- EAD EXHAUST AIR DUCT
- CENTRIFUGAL EXHAUST FAN
- IN-LINE EXTRACT FAN
- AXIAL EXTRACT FAN
- FLOW PIPE
- RETURN PIPE
- UNDERGROUND
- U/T UNDERFLOOR
- AFC ABOVE FALSE CEILING
- F/A FROM ABOVE
- T/A TO ABOVE
- F/B FROM BELOW
- T/B TO BELOW

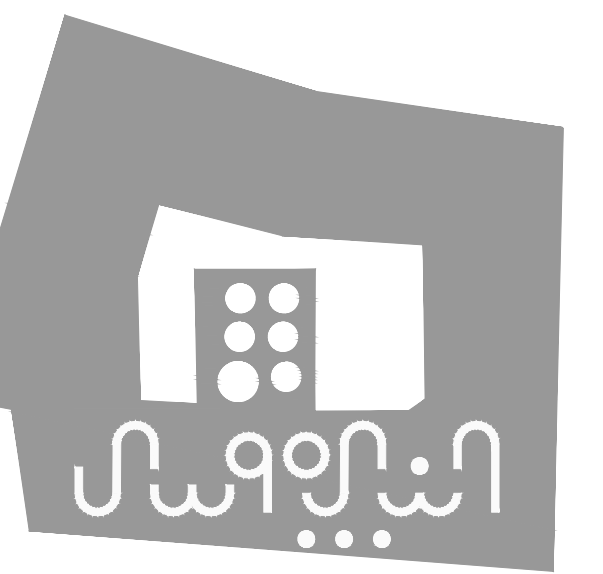

PROJECT:

Securing Professional Services for the Architectural Restoration and Rehabilitation Designs, Archaeological Documentation and Orientation Training, Including Tender Documents Preparation and Site Supervision for Conservation and Rehabilitation Works of Maqam Al-Nabi Musa in Jericho Governorate

Support to Development of Cultural Tourism

DESIGN WORKS:

Jerusalem Design Center

ELECTRICAL WORKS:

-Eng. Midhat AlSharif

MECHANICAL WORKS:

-Elite Mechanical Consultants

SHEET NAME:

FIRST FLOOR

AC&VENTILATION PLAN

SCALE: 1:100

(OF PILOTTED ON AD)

For Review

For Approval

For Tender

For Construction

DATE: July-2016

EDITION:


MECHANICAL

SHEET NO.

M402




0 2.5 5.0 10

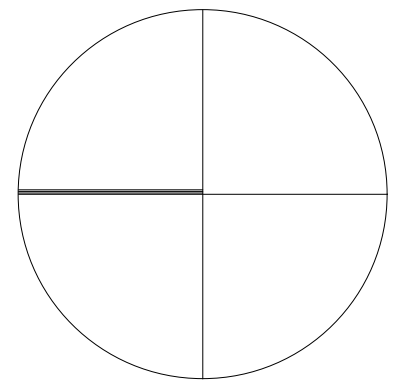

NOTES & LEGEND:

- WALL MOUNTED PAROOL UNIT
- CEILING SUPPLY GRILL (WITH DAMPERS)
- RETURN GRILL
- EXHAUST SQUARE CEILING GRILL
- ROOM THERMOSTAT
- SAD SUPPLY AIR DUCT
- EDU EXHAUST AIR DUCT
- CENTRIFUGAL EXHAUST FAN
- IN-LINE EXTRACT FAN
- AXIAL EXTRACT FAN
- FLOW PIPE
- RETURN PIPE
- U/D UNDERGROUND
- U/T UNDERFILE
- AFC ABOVE FALSE CEILING
- F/A FROM ABOVE
- T/A TO ABOVE
- F/B FROM BELOW
- T/B TO BELOW

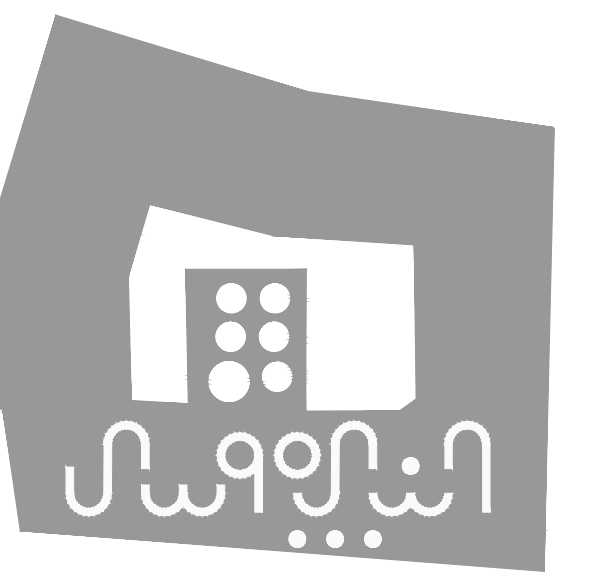

PROJECT:

Securing Professional Services for the Architectural Restoration and Rehabilitation Designs, Archaeological Documentation and Orientation Training, Including Tender Documents Preparation and Site Supervision for Conservation and Rehabilitation Works of Maqam Al-Nabi Musa in Jericho Governorate

Support to Development of Cultural Tourism

DESIGN WORKS:

jdc -Jerusalem Design Center

ELECTRICAL WORKS:

-Eng .Midhat AlSharif

MECHANICAL WORKS:

elite -Elite Mechanical Consultants

SHEET NAME:

UPPER FIRST FLOOR

AC&VENTILATION PLAN

SCALE: 1:100

(IF PILOTTED ON A3)

EDITION:

MECHANICAL

SHEET NO.

M403


DATE: July-2016

jdc Jerusalem Design Center
Architects, Engineers & Consultants

Phone: 02 234 3096 | Fax: 02 234 3719 | Email: info@jdc.ps

NOTES & LEGEND:

- POLYETHYLENE IRRIGATION PIPE
- I IRRIGATION COLLECTOR
- K SHUT OFF VALVE
- U/G UNDERGROUND
- U/T UNDERFILE
- F/A FROM ABOVE
- T/A TO ABOVE
- F/B FROM BELOW
- T/B TO BELOW

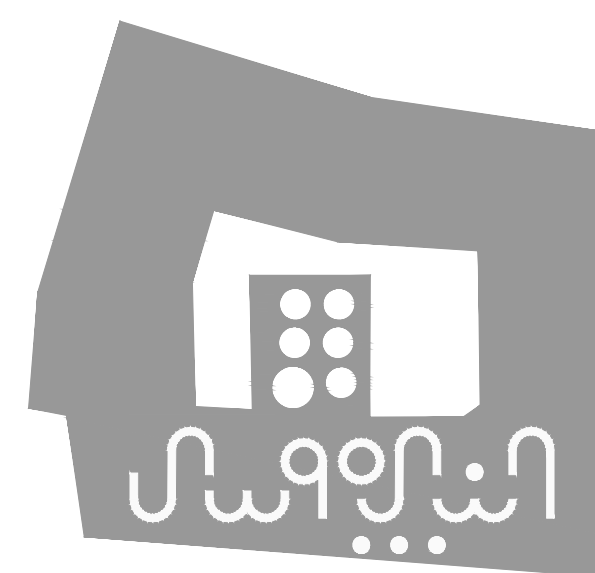

PROJECT:

Securing Professional Services for the Architectural Restoration and Rehabilitation Designs, Archaeological Documentation and Orientation Training, Including Tender Documents Preparation and Site Supervision for Conservation and Rehabilitation Works of Maqam Al-Nabi Musa in Jericho Governorate

Support to Development of Cultural Tourism

DESIGN WORKS:

jdc -Jerusalem Design Center

ELECTRICAL WORKS:

-Eng. Midhat AlSharif

MECHANICAL WORKS:

elite -Elite Mechanical Consultants

SHEET NAME:

GROUND FLOOR
IRRIGATION PLAN

SCALE: 1:100

(OF PLOTTED ON A3)

EDITION:

MECHANICAL

For Review

For Approval

For Tender

For Construction

DATE: July-2016

SHEET NO.

M500

jdc

Jerusalem Design Center

Architects, Engineers & Consultants

Phone: 02 234 3096 | Fax: 02 234 3719 | Email: info@jdc.ps

FOUNTAIN PUMP SCHEDULE													
PUMP LABEL	SERVED AREA	LOCATION	FLOW (M3/HR)	HEAD (M)	MOTOR DATA				QUANTITY			TYPE	SYSTEM
					RPM	KW	Ø	VOLTS	ON DUTY	STAND BY	TOTAL		
SMP-02	GROUND FLOOR FOUNTAIN	FOUNTAIN	7.2	7	2900	0.3	1	220	1	0	1	SUBMERSIBLE PUMP	FOUNTAIN USE

COLD & HOT WATER PUMPS SCHEDULE

PUMP LABEL	LOCATION	FLOW (L/S)	HEAD (M)	MOTOR DATA				QUANTITY			TYPE	FUNCTION	SERVED AREA
				RPM	KW	ø	VOLTS	ON DUTY	STAND BY	TOTAL			
LP-1	UNDERGROUND	4.0	15	2900	1.0	3	380	1	1	2	BASE-MOUNTED END-SUCTION STAINLESS STEEL BODY&IMPELLER	LIFTING PUMP	FLUSH WATER SYSTEM
BCWP-1	SITE PUMP ROOM	3.0	35	2900	2.0	3	380	1	1	2	BOOSTER PUMP MULTISTAGE/VARIABLE SPEED STAINLESS STEEL BODY&IMPELLER	BOOSTER PUMP	DOMESTIC COLD WATER
FWP-1	SITE PUMP ROOM	6.3	40	2900	4.5	3	380	1	1	2	BOOSTER PUMP MULTISTAGE/VARIABLE SPEED STAINLESS STEEL BODY&IMPELLER	BOOSTER PUMP	FLUSH WATER SYSTEM
CP-1	MECHANICAL ROOM	0.2	7	2900	0.2	1	220	1	0	1	INLINE CENTRIFUGAL STAINLESS STEEL BODY&IMPELLER	CIRCULATING PUMP RETURN HOT	HOT WATER RETURN SYSTEM
IRP-1	MECHANICAL ROOM	0.5	30	2900	0.5	3	380	1	0	1	BOOSTER PUMP MULTISTAGE/VARIABLE SPEED STAINLESS STEEL BODY&IMPELLER	IRRIGATION PUMP	IRRIGATION SYSTEM

FIRE FIGHTING PUMPS SCHEDULE											
PUMP DESCRIPTION	LOCATION	FLOW (gpm)	HEAD (M)	MOTOR DATA				QUANTITY			TYPE
				RPM	KW	ø	VOLTS	ON DUTY	STAND BY	TOTAL	
FP-1	SITE PUMP ROOM	100	60	2900	7.0	3	380	1	1	2	ELECTRIC PUMP (FIRE FIGHTING SYSTEM)

CLASS K FIRE FIGHTING EXTINGUISHER	
CAPACITY(KG)	6.0
UL FIRE RATING	K
AGENT TYPE	POTASSIUM ACETATE
CYLINDRICAL MATERIAL	STAINLESS STEEL
VALVE MATERIAL	PLATED BRASS
HANDLE MATERIAL	STAINLESS STEEL
EXPELLANT	NITROGEN/AIR
OPERATING PRESSURE@70°F	100
TEMPREATURE RANGE(°C)	4.4 TO 48.9
AGENT FLOW RATE(KG/SEC.)	N/A
NOM.DISCHARGE TIME(SEC)	50 TO 55
MAXIMUM TRAVEL DISTANCE TO EXT.(M)	9.0
DISCHARGE RANGE(M)	2.4 TO 3.7
UNIT HEIGHT(CM)	49.5
UNIT WIDTH(CM)	22.2
UNIT DEPHT(CM)	17.8
USCG APPROVAL	N/A
LISTING	UL LISTED - MEETS D.O.T. REQUIRMENTS


ABC FIRE FIGHTING EXTINGUISHER	
CAPACITY(KG)	5.0
UL FIRE RATING	4-A:80-B:C
AGENT TYPE	ABC
CYLINDRICAL MATERIAL	STEEL
VALVE MATERIAL	ALUMINUM
HANDLE MATERIAL	PLATED STEEL
EXPELLANT	NITROGEN
OPERATING PRESSURE@70°F	195
TEMPREATURE RANGE(°C)	-40 TO 48.9
AGENT FLOW RATE(KG/SEC.)	0.23
NOM.DISCHARGE TIME(SEC)	22
MAXIMUM FLOOR AREA FOR EXTN.(M²)	1045
MAXIMUM TRAVEL DISTANCE TO EXT.(M)	22
DISCHARGE RANGE(M)	4.9 TO 6.1
UNIT HEIGHT(CM)	48.1
UNIT WIDTH(CM)	19.7
UNIT DEPHT(CM)	13.3
USCG APPROVAL	TYPEA SIZE# TYPE B:C SIZE#
LISTING	UL LISTED AND USCG APPROVED-MEETS D.O.T. REQUIRMENTS

PUMP SCHEDULE(SMP-01)	
TYPE	SUBMERSIBLE GRINDER PUMP VERTICAL SINGLE-STAGE CAST IRON SUBMERSIBLE PUMP WITH INTEGRATED SUBMERSIBLE 3-PHASE MOTOR
DESCRIPTION	THE PUMP IS EQUIPPED WITH A HARDENED STEEL CUTTER SYSTEM SUITABLE FOR PUMPING WASTEWATER AND SEWAGE IN PRESSURIZED SYSTEMS. THE PUMP HAS A DOUBLE SHAFT SEAL AND AN INTERMEDIATE OIL CHAMBER PRE-FILED WITH SPECIAL OIL THE MOTOR IS INSULATION CLASS F AND HAS LONG-LIFE DEEP-GROOVE GREASED-FOR-LIFE BALL BEARINGS THE PUMP INSTALLATION ON AN AUTO-COUPLING SYSTEM
ACTUAL CALCULATED FLOW(M3/HR)	6 M3/HR
RESULTING HEAD OF THE PUMP(M)	7
TYPE OF IMPELLER	CUTTER SYSTEM
PUMP HOUSING	CAST IRON
IMPELLER	CAST IRON
ELECTRICAL DATA :	
POWER INPUT (KW)	0.2
MAIN FREQUENCY (Hz)	50
RATED VOLTAGE	230V
Quantity	2(1 ONDUTY -1 STANDBY)

SOFTNER	
TYPE	DUAL AUTOMATIC, FULLY AUTOMATIC, ONE COLUMN IN OPERATION WHILE THE SECOND IS IN REGENERATION OR STAND BY, SOFTENERS CHANGE AND REGENERATION INITIATION ARE AUTOMATIC BY WATER FLOW MEASUREMENT. ALL THE SYSTEM IS BUILT OF PLASTIC, CORROSION RESISTANT MATERIALS.
GRAIN CAPACITY	30,000
MAXIMUM FLOW RATE (M3/HR)	1.2
BRINE TANK	24"X40" HDPE CONSTRUCTION FULLY ASSEMBLED WITH SAFETY BRINE VALVE
VALVE DIAMETER	1"
CONTROL	METER CONTROL
VESSEL	9"X35"
CONSTRUCTION	2 POLYETHYLENE LINED FRP COLUMNS-RESISTANT TO PRESSURE AND CHEMICALS
ION EXCHANGE RESIN	CONSTRUCTION ABS PLASTIC, DOUBLE PISTON VALVE ,OPERATED WITH COMPRESSED AIR BY THE WATER LINE PRESSURE
OPERATING PRESSURE	1.5-6 BAR (RESISTANT TO 10 BAR)
PIPING	PVC SOCKET WELDED
CONTROL	-PROGRAMMABLE MICROPROCESSOR TYPE. -REGENERATION BY VOLUME WITH DIGITAL DISPLAY OF AVAILABLE WATER QUANTITY AND REGENERATION STEPS. -OPTIONAL REGENERATION B PUSH -BUTTON OR EXTERNAL SIGNAL. -OPERATED BY 12 VOLT SUPPLY (A SUITABLE TRANSFORMER IS INCLUDED .INTERNAL RECHARGEABLE BATTERY FOR MEMORY BACK UP. -HIGH RELIABILITY CONTROLLER VALVE SYSTEM.

FM-200 SYSTEM DESIGN DATA	
SERVED AREA	LOW CURRENT&SERVICES ROOM
DESIGN STANDARD	NFPA -2001
EXTINGUISHANT AGENT	FM-200 (HFC-227ea)
DESIGN CONCENTRATION	7 %
DESIGN TEMP.	20°C
MAXIMUM DISCHARGE TIME	10 Sec.
HAZARD PROTECTED	PABX DATA ROOM
FLOOD FACTOR	0.5483 KG/M3
ENCLOSURE'S	LOW VOLTAGE ROOM
AREA	10.5 M2
HEIGHT	3 M
VOLUME	31.5 M3
TOTAL REQUIRED AGENT	20 Kg

NOTES & LEGEND:

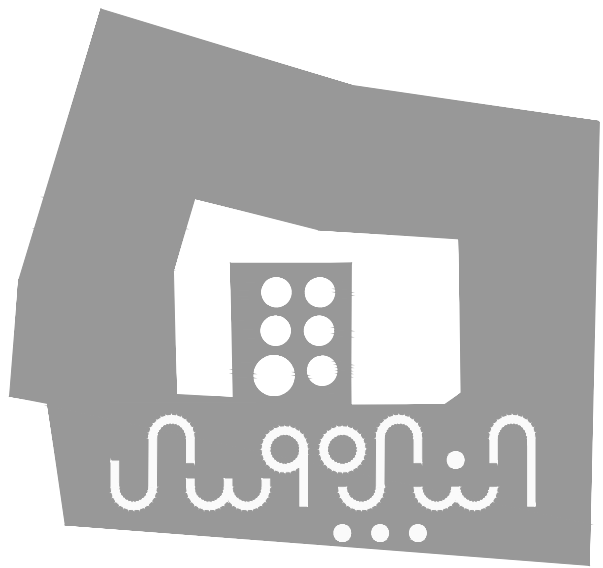

PROJECT:

Securing Professional Services for the Architectural Restoration and Rehabilitation Designs, Archaeological Documentation and Orientation Training, Including Tender Documents Preparation and Site Supervision for Conservation and Rehabilitation Works of Maqam Al-Nabi Musa in Jericho Governorate

Support to Development of Cultural Tourism

DESIGN WORKS:

jdc -Jerusalem Design Center

ELECTRICAL WORKS:

-Eng .Midhat AlSharif

MECHANICAL WORKS:

elite -Elite Mechanical Consultants

SHEET NAME:

SCHEDULE OF EQUIPMENTS- 1

SCALE: N.T.S. EDITION: MECHANICAL

☐ For Review
☐ For Approval
☒ For Tender
☐ For Construction

DATE: July-2016



UNDERGROUND FLOOR

FANCOIL UNITS SCHEDULE										
FAN COIL NO.	TYPE	AIR FLOW (L/S)	COOLING CAPACITY TOTAL (KW)		SENSIBLE (KW)	WATER (L/S)	HEATING CAPACITY TOTAL (KW)		ELEC. (W)	QTY
FC-B-01	FLOOR MOUNTED	204	2.4	2.1	0.12	1.1	0.05	93	1	
FC-B-02	FLOOR MOUNTED	315	4.1	3.2	0.20	1.7	0.08	251	1	
FC-B-03	FLOOR MOUNTED	315	4.1	3.3	0.20	1.8	0.09	251	1	
FC-B-04	FLOOR MOUNTED	315	4.6	3.6	0.22	1.9	0.09	251	1	
FC-B-05	FLOOR MOUNTED	315	3.7	2.9	0.18	1.6	0.08	251	1	
FC-B-06	FLOOR MOUNTED	358	5.9	4.5	0.28	2.5	0.12	305	1	
FC-B-07	FLOOR MOUNTED	204	2.9	2.4	0.14	1.0	0.05	93	1	
FC-B-08	FLOOR MOUNTED	315	3.7	3.0	0.18	1.3	0.06	251	1	
FC-B-09	FLOOR MOUNTED	315	4.7	3.9	0.23	1.6	0.08	251	1	
TOTAL(KW)			36.1			14.5				

-FANCOIL TO BE SELECTED ON MEDIUM SPEED
-ENTERING/LEAVING WATER TEMP.FOR COOLING (7°C/12°C)
-ENTERING/LEAVING WATER TEMP.FOR HEATING (45°C/40°C)
-INDOOR TEMP.FOR COOLING (23°C)
-INDOOR TEMP.FOR HEATING (23°C)

FANS SCHEDULE											
FAN LABLE	TYPE	LOCATION	APPLICATION	FLOW (L/S)	HEAD (PA)	MOTOR DATA					QNT.
						RPM	KW	VOLTS	ø	HZ	
FAN#1	GLASS MOUNTED AXIAL FAN	STORAGES,OFFICES SHOPS&ROOMS	VENTILATION	25	—	2500	0.10	220	1	50	48
FAN#1'	WALL MOUNTED AXIAL FAN	STORAGES,OFFICES SHOPS&ROOMS	VENTILATION	25	—	2500	0.10	220	1	50	13
FAN#2	GLASS MOUNTED AXIAL FAN	STORAGES,MUSEUM TOILETS&ROOMS	VENTILATION &DIRTY EXTRACT	35	—	2500	0.10	220	1	50	20
FAN#2'	WALL MOUNTED AXIAL FAN	STORAGES,MUSEUM TOILETS&ROOMS	VENTILATION &DIRTY EXTRACT	35	—	2500	0.10	220	1	50	8
FAN#3	INLINE CENTRIFUGAL DUCTED FAN	PUBLIC TOILETS GROUND LEVEL	DIRTY EXTRACT	385	100	2300	0.30	220	1	50	1
FAN#4	INLINE CENTRIFUGAL DUCTED FAN	PUBLIC TOILETS RESTURANT	DIRTY EXTRACT	140	75	2750	0.15	220	1	50	1
FAN#5	CENTRIFUGAL EXTRACT FAN	KITCHEN GROUND FLOOR	KITCHEN HOOD	495	100	1400	0.50	220	1	50	1
FAN#6	INLINE CENTRIFUGAL DUCTED FAN	KITCHEN CEILING GROUND FLOOR	DIRTY EXTRACT	200	100	2750	0.20	220	1	50	1
FAN#7	GLASS MOUNTED AXIAL FAN	RESTURANT GROUND FLOOR	VENTILATION	260	—	2700	0.10	220	1	50	2
FAN#8	WALL MOUNTED AXIAL FAN	RECEPTION GROUND FLOOR	VENTILATION	45	—	2500	0.10	220	1	50	1
FAN#9	GLASS MOUNTED AXIAL FAN	MOSQUE&MUSEUM GROUND FLOOR	VENTILATION	200	—	2500	0.10	220	1	50	4
FAN#10	GLASS MOUNTED AXIAL FAN	COOKING/BASEMENT MUSEUM/FIRST	VENTILATION	65	—	2200	0.10	220	1	50	4

MULTIPIPE CHILLER(MPCH-1)	
DESCRIPTION	AIR COOLED FOUR PIPE WITH HYDRONIC MODULE INCLUDING TWO PUMPS FOR HEATING COIL AND TWO FOR HEATING (1ON,1STAND-BY)
NET COOLING CAPACITY EVAP.12°C/7°C-AIR(DB)35°C	345 KW
TOTAL POWER POWER INPUT IN COOLING	149 KW
EER	3.13
NET HEATING CAPACITY EVAP.40°C/45°C-AIR(DB)2°C	330 KW
TOTAL POWER POWER INPUT IN HEATING	125.1 KW
MAIN POWER SUPPLY	400/3/50
HEATING COEFFICIENT OF PERFORMANCE	3.52
SYSTEM DATA	
NO. OF REFRIGERANT CIRCUITS	2
COMPRESSOR	
NO. OF COMPRESSORS PER CIRCUIT	4
TYPE	SCROLL
EVAPORATOR	
QUANTITY	1
TYPE	BPHE
CONDENSOR	
TYPE	FIN AND TUBE
FAN	
QUANTITY	6
POWER PER FAN (KW)	1.5
DRIVE TYPE	
PHR	DIRECT
HEAT-EXCHANGER TYPE	
BRAZED PLATES	
HYDRAULIC DATA	
HIGH PRESSURE HEAD PUMPS NO. (450 KPA)	2 PUMPS-COOLING MODE 2PUMPS-HEATING MODE (1ON, 1 STAND-BY)
POWER PER PUMP (KW)	18.5
COLD WATER FLOW(L/S)	16.6
HOT WATER FLOW(L/S)	15.8
TOTAL WEIGHT(KG)	4552
APPROXIMATE DIMENSIONS(MM)	4480X2250X2312 (LXWXH)
Qt.	1

NOTES:

1. EVAPORATOR WATER (IN/OUT) = 12/7°C ; CONDENSER AIR (IN) = 43°C
2. CONDENSER WATER (IN/OUT) = 40/45°C; EVAPORATOR AIR (IN) = 10°C
3. EVAPORATOR WATER (IN/OUT) = 12/7°C ; CONDENSER WATER (IN/OUT) = 40/45°C
4. SOUND POWER LEVEL DETERMINED IN ACCORDANCE WITH ISO 3744 REGULATIONS AND THE EUROVENT CERTIFICATION.
- 5.NOTE FOR ELECTRICAL LOAD, MUST SUM COMPRESSORS POWER+FANS POWER+PUMPS POWER.

GROUND FLOOR

FANCOIL UNITS SCHEDULE									
FAN COIL NO.	TYPE	AIR FLOW (L/S)	COOLING CAPACITY TOTAL (KW)	SENSIBLE (KW)	WATER (L/S)	HEATING CAPACITY TOTAL (KW)	WATER (L/S)	ELEC. (W)	QTY
FC-G-01	FLOOR MOUNTED	315	4.6	4.1	0.22	2.3	0.11	251	1
FC-G-02	FLOOR MOUNTED	358	5.2	4.5	0.25	2.2	0.11	305	1
FC-G-03	FLOOR MOUNTED	520	7.8	7.0	0.37	4.0	0.19	394	2
FC-G-04	FLOOR MOUNTED	358	6.0	5.3	0.29	2.9	0.14	305	1
FC-G-05	FLOOR MOUNTED	204	3.4	2.7	0.16	1.2	0.06	93	1
FC-G-06	FLOOR MOUNTED	520	7.9	5.6	0.38	2.2	0.11	394	1
FC-G-07	FLOOR MOUNTED	358	6.7	5.0	0.32	1.8	0.09	305	1
FC-G-08	FLOOR MOUNTED	520	7.4	5.2	0.36	2.3	0.11	394	1
FC-G-09	FLOOR MOUNTED	315	3.7	3.3	0.18	1.5	0.07	251	1
FC-G-10	FLOOR MOUNTED	315	3.7	3.3	0.18	1.5	0.07	251	1
FC-G-11	FLOOR MOUNTED	204	2.8	2.4	0.13	1.4	0.07	93	1
FC-G-12	FLOOR MOUNTED	315	3.5	3.0	0.17	1.6	0.08	251	2
FC-G-13	FLOOR MOUNTED	358	6.3	5.9	0.30	1.7	0.08	305	1
FC-G-14	FLOOR MOUNTED	358	6.3	5.9	0.30	1.7	0.08	305	1
FC-G-15	FLOOR MOUNTED	358	6.4	6.0	0.30	1.7	0.08	305	1
FC-G-16	FLOOR MOUNTED	358	6.7	6.3	0.32	1.8	0.08	305	1
FC-G-17	FLOOR MOUNTED	358	6.7	6.3	0.32	1.8	0.08	305	1
FC-G-18	CEILING MOUNTED	358	5.7	4.9	0.27	3.0	0.14	305	1
FC-G-19	FLOOR MOUNTED	315	2.2	1.9	0.11	1.0	0.05	125	2
FC-G-20	CEILING MOUNTED	520	7.4	5.4	0.36	2.9	0.14	394	2
FC-G-21	FLOOR MOUNTED	204	3.2	2.7	0.15	1.4	0.07	93	1
FC-G-22	FLOOR MOUNTED	204	2.2	1.9	0.11	1.0	0.05	93	1
FC-G-23	FLOOR MOUNTED	520	7.6	6.8	0.33	3.4	0.16	394	1
FC-G-24	FLOOR MOUNTED	315	4.7	4.3	0.23	1.3	0.06	251	1
FC-G-25	FLOOR MOUNTED	358	5.3	4.8	0.25	2.7	0.13	305	1
FC-G-26	FLOOR MOUNTED	358	6.6	5.8	0.32	3.4	0.16	305	2
FC-G-27	FLOOR MOUNTED	520	7.3	5.2	0.35	2.3	0.11	394	3
FC-G-28	FLOOR MOUNTED	315	4.0	3.5	0.19	1.9	0.09	251	1
FC-G-29	FLOOR MOUNTED	600	9.5	6.8	0.46	3.1	0.15	553	5
FC-G-30	FLOOR MOUNTED	315	4.2	3.5	0.20	1.7	0.08	251	1
FC-G-31	FLOOR MOUNTED	204	3.0	2.6	0.14	1.3	0.06	93	1
FC-G-32	FLOOR MOUNTED	600	10.3	8.0	0.49	4.0	0.19	553	2
FC-G-33	FLOOR MOUNTED	520	8.7	6.5	0.42	3.7	0.18	394	1
FC-G-34	FLOOR MOUNTED	204	3.0	2.7	0.14	1.1	0.05	93	1
FC-G-35	FLOOR MOUNTED	204	3.2	2.8	0.15	1.2	0.06	93	1
FC-G-36	FLOOR MOUNTED	358	5.1	4.1	0.24	1.9	0.09	305	1
FC-G-37	FLOOR MOUNTED	204	3.3	3.0	0.16	1.4	0.07	93	1
FC-G-38	FLOOR MOUNTED	204	3.0	2.7	0.14	1.2	0.06	93	1
FC-G-39	FLOOR MOUNTED	204	3.2	2.9	0.15	1.3	0.06	93	1
FC-G-40	FLOOR MOUNTED	520	7.2	5.3	0.35	2.9	0.14	394	1
FC-G-41	FLOOR MOUNTED	520	8.3	6.1	0.40	3.2	0.15	394	6
TOTAL(KW)			355.2			135.8			

PUMPS SCHEDULE												
PUMP DESCRIPTION	SERVED AREA OR EQUIPMENT	LOCATION	FLOW (L/S)	HEAD (M)	MOTOR DATA				QUANTITY			TYPE
					RPM	KW	ø	VOLTS	ON DUTY	STAND BY	TOTAL	
CIRCULATING PUMP (HWSP-1)	HOT WATER CYLINDER	MECHANICAL ROOM	2.0	10	1450	0.5	3	380	1	1	2	CENTRIFUGAL END SUCTION CONSTANT SPEED
CIRCULATING PUMP (HWSP-2)	SECONDARY PUMP HEATING CIRCUIT	MECHANICAL ROOM	13.5	35	1450	8.0	3	380	1	1	2	CENTRIFUGAL END SUCTION VARIABLE SPEED PUMP
CIRCULATING PUMP (CHWSP)	SECONDARY PUMP COOLING CIRCUIT	MECHANICAL ROOM	33.1	35	1450	19.0	3	380	1	1	2	CENTRIFUGAL END SUCTION VARIABLE SPEED PUMP


SCHEDULE OF VESSELS TANKS							
REF. / EQUIPMENT DESIGNATION	LOCATION	DESCRIPTION	QUANTITY	DUTY	STAND BY	CAPACITY (L)	WORKING PRESSURE (Bar)
EX-VESSEL(1) (FOR HEAT CIRCUIT)	MECHANICAL ROOM	DIAPHRAGM TYPE INCLUDING :- A-EXPANSION TANK	1	—	—	100	6.0
EX-VESSEL(2) (FOR COOLING CIRCUIT)	MECHANICAL ROOM	DIAPHRAGM TYPE INCLUDING :- A-EXPANSION TANK	1	—	—	200	6.0

FIRST & UPPER FIRST FLOORS

FANCOIL UNITS SCHEDULE									
FAN COIL NO.	TYPE	AIR FLOW (L/S)	COOLING CAPACITY		HEATING CAPACITY (L/S)	CAPACITY (W)	ELEC. (W)	QTY	
			TOTAL (KW)	SENSIBLE (KW)					
FC-F-01	FLOOR MOUNTED	358	5.4	5.1	0.26	2.3	0.11	305	1
FC-F-02	FLOOR MOUNTED	358	4.9	4.6	0.24	2.0	0.10	305	1
FC-F-03	FLOOR MOUNTED	315	4.3	4.0	0.21	1.7	0.08	251	1
FC-F-04	FLOOR MOUNTED	315	4.2	3.9	0.20	2.5	0.12	251	1
FC-F-05	FLOOR MOUNTED	358	5.3	4.8	0.25	2.2	0.11	305	1
FC-F-06	FLOOR MOUNTED	358	4.7	4.2	0.23	2.5	0.12	305	1
FC-F-07	FLOOR MOUNTED	520	7.4	6.6	0.36	3.6	0.17	394	1
FC-F-08	FLOOR MOUNTED	358	4.7	4.3	0.23	2.2	0.11	305	1
FC-F-09	FLOOR MOUNTED	315	4.1	3.9	0.20	1.8	0.09	251	1
FC-F-10	FLOOR MOUNTED	358	5.6	5.2	0.27	2.8	0.13	305	1
FC-F-11	FLOOR MOUNTED	600	9.8	8.9	0.47	4.0	0.19	553	1
FC-F-12	FLOOR MOUNTED	358	6.3	5.8	0.30	3.0	0.14	305	1
FC-F-13	FLOOR MOUNTED	358	5.1	4.6	0.24	2.6	0.13	305	1
FC-F-14	FLOOR MOUNTED	358	4.9	4.5	0.24	2.2	0.11	305	1
FC-F-15	FLOOR MOUNTED	358	4.8	4.4	0.23	2.2	0.11	305	1
FC-F-16	FLOOR MOUNTED	358	6.3	5.8	0.30	2.9	0.14	305	1
FC-F-17	FLOOR MOUNTED	358	6.6	6.1	0.32	3.2	0.15	305	1
FC-F-18	FLOOR MOUNTED	204	2.9	2.7	0.14	1.6	0.08	102	1
FC-F-19	FLOOR MOUNTED	315	4.5	4.3	0.22	2.3	0.11	251	1
FC-F-20	FLOOR MOUNTED	358	5.0	4.6	0.24	2.3	0.11	305	1
FC-F-21	FLOOR MOUNTED	315	3.8	3.6	0.18	2.0	0.10	251	1
FC-F-22	FLOOR MOUNTED	358	6.2	5.6	0.30	2.7	0.13	305	1
FC-F-23	FLOOR MOUNTED	520	7.8	7.0	0.36	3.0	0.14	394	1
FC-F-24	FLOOR MOUNTED	520	7.4	6.7	0.34	3.0	0.14	394	1
FC-F-25	FLOOR MOUNTED	520	7.0	6.2	0.33	2.9	0.14	394	1
FC-F-26	FLOOR MOUNTED	520	7.6	6.6	0.36	3.2	0.15	394	1
FC-F-27	FLOOR MOUNTED	520	7.5	6.5	0.36	3.1	0.15	394	1
FC-F-28	FLOOR MOUNTED	520	8.0	6.8	0.38	3.4	0.15	394	1
FC-F-29	FLOOR MOUNTED	600	9.7	8.6	0.46	4.7	0.23	553	1
FC-F-30	FLOOR MOUNTED	520	8.7	7.3	0.41	4.0	0.17	394	1
FC-F-31	FLOOR MOUNTED	600	10.5	7.7	0.49	5.2	0.25	553	1
FC-F-32	FLOOR MOUNTED	600	9.6	7.9	0.46	4.7	0.20	553	1
FC-F-33	FLOOR MOUNTED	600	10.7	8.8	0.49	5.1	0.24	553	1
FC-UF-01	FLOOR MOUNTED	520	6.8	6.2	0.33	2.8	0.13	394	2
FC-UF-02	FLOOR MOUNTED	358	6.0	5.4	0.29	3.1	0.15	305	1
TOTAL(KW)			230.9			105.6			

NOTES & LEGEND:

- FLUSH WATER P.P.R. PIPE
- SOFT WATER P.P.R. PIPE
- HOT WATER P.P.R. PIPE
- HOT WATER P.P.R. PIPE
- DOMESTIC COLD WATER P.P.R. PIPE
- HOT WATER POLYETHYLENE PIPE
- COLD WATER POLYETHYLENE PIPE
- GAS SOFT COPPER PIPE
- FLUSH WATER POLYETHYLENE PIPE
- IRRIGATION PIPE
- FLOW PIPE FROM HEAT PUMP
- RETURN PIPE TO HEAT PUMP
- FLOW/RETURN TO SOLAR PANELS
- SHUT OFF VALVE
- PIPE VENT
- STRAINER
- NON RETURN VALVE
- PRESSURE REDUCING VALVE
- AUTOMATIC AIR VENT
- REGULATING VALVE

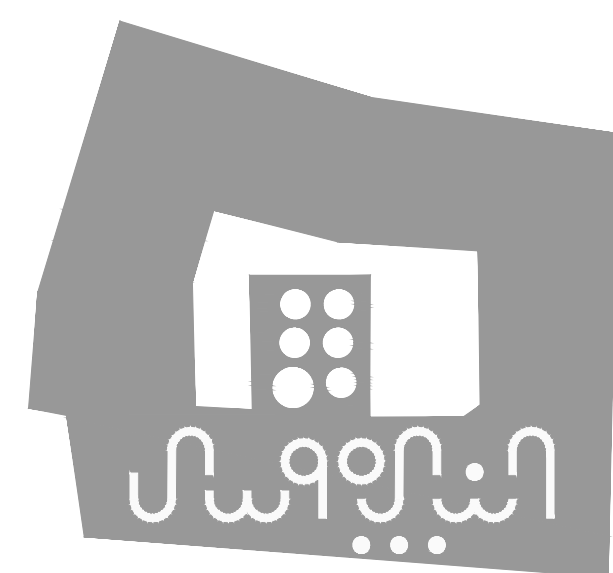

EUROPEAN UNION

UNDP
50 YEARS
الدولة الفلسطينية
Empowered lives. Resilient nations.

Support to Development of Cultural Tourism

DESIGN WORKS:

Jerusalem Design Center

ELECTRICAL WORKS:

-Eng .Midhat AlSharif

MECHANICAL WORKS:

-Elite Mechanical Consultants

SHEET NAME:

*SCHEMATIC FOR
WATER PIPING*

SCALE:

N.T.S

EDITION:

MECHANICAL

For Review

For Approval


For Tender

For Construction

SHEET NO.

M602

DATE: July-2016

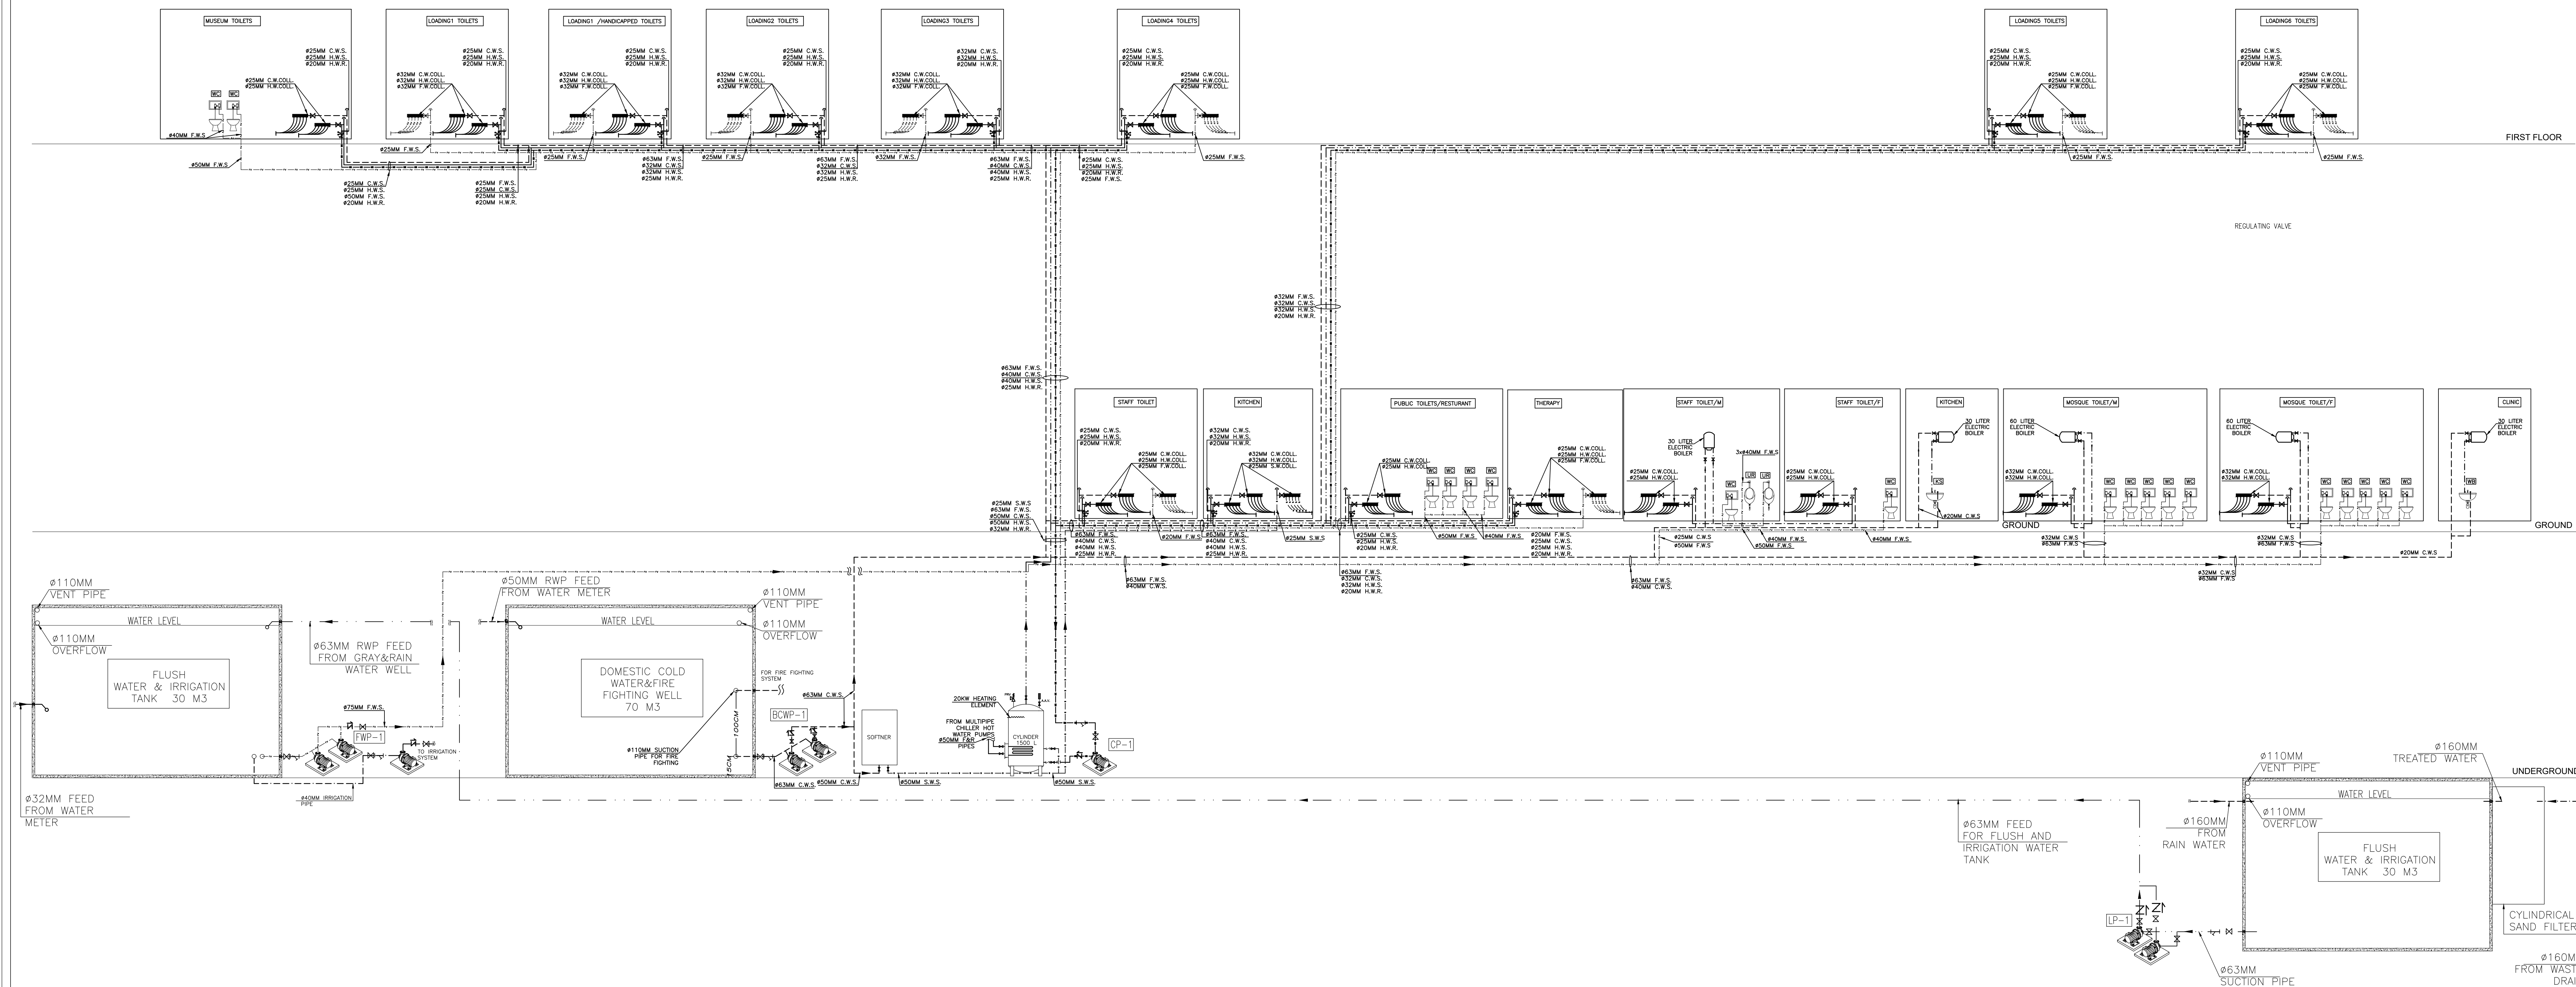

NOTES & LEGEND:

FHC-1
#25 MM, 30M LONG HOSE
REEL WITH COMBINED
PRESSURE
REDUCING TO LIMIT PRESSURE
TO 2.4 BAR
4.5 POWDER FIRE EXTINGUISHER
5KG CO2 FIRE EXTINGUISHER

FHC-2
#25 MM, 30M LONG
HOSE BACK
PRESSURE
REDUCING TO LIMIT PRESSURE
TO 4.5 BAR
4.5 POWDER FIRE EXTINGUISHER
5KG CO2 FIRE EXTINGUISHER


F.P. FIRE PIPE

PRV PRESSURE REDUCING VALVE

SOV SHUT OFF VALVE

STR STRAINER

NRV NON RETURN VALVE

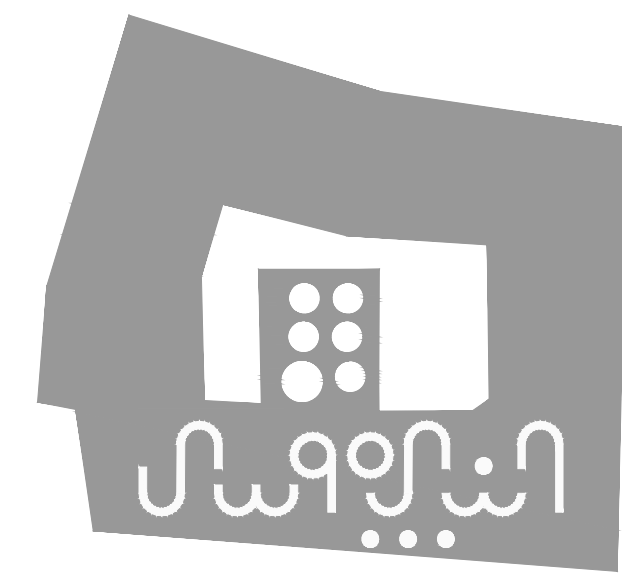

PROJECT:

**Securing Professional Services for the
Architectural Restoration and
Rehabilitation Designs, Archaeological
Documentation and Orientation Training,
Including Tender Documents Preparation
and Site Supervision for Conservation and
Rehabilitation Works of Maqam Al-Nabi
Musa in Jericho Governorate**

Support to Development of Cultural Tourism

DESIGN WORKS:

Jerusalem Design Center

ELECTRICAL WORKS:

-Eng .Midhat AlSharif

MECHANICAL WORKS:

-Elite Mechanical Consultants

SHEET NAME:

*SCHEMATIC FOR
FIRE FIGHTING*

SCALE:

N.T.S

EDITION:

MECHANICAL

For Review

For Approval


For Tender


For Construction

DATE: July-2016

SHEET NO.

M603

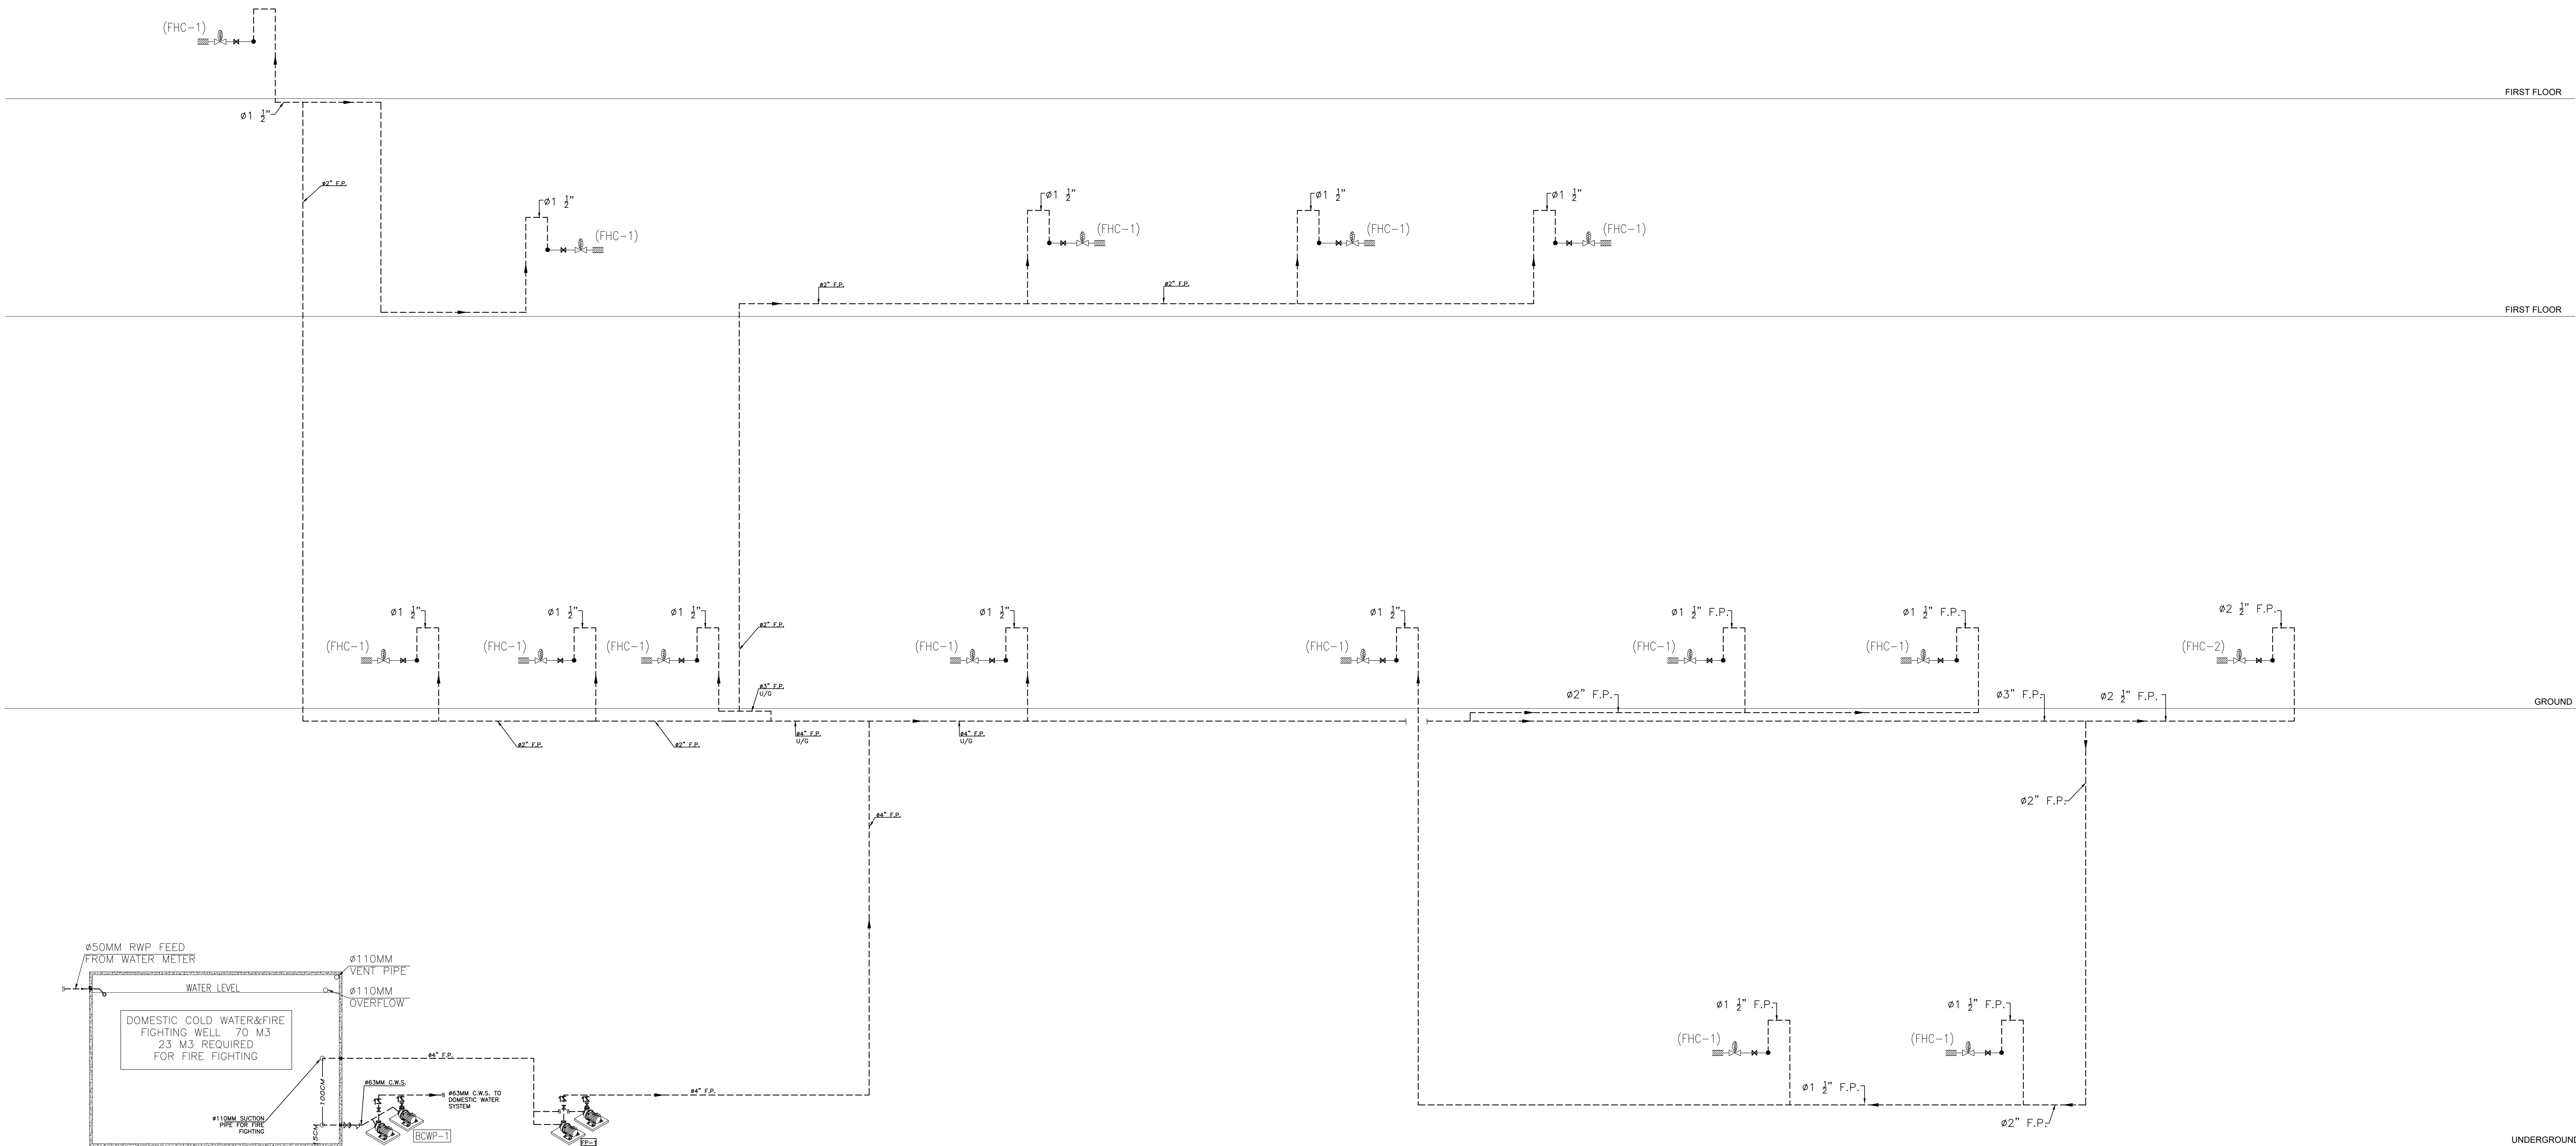

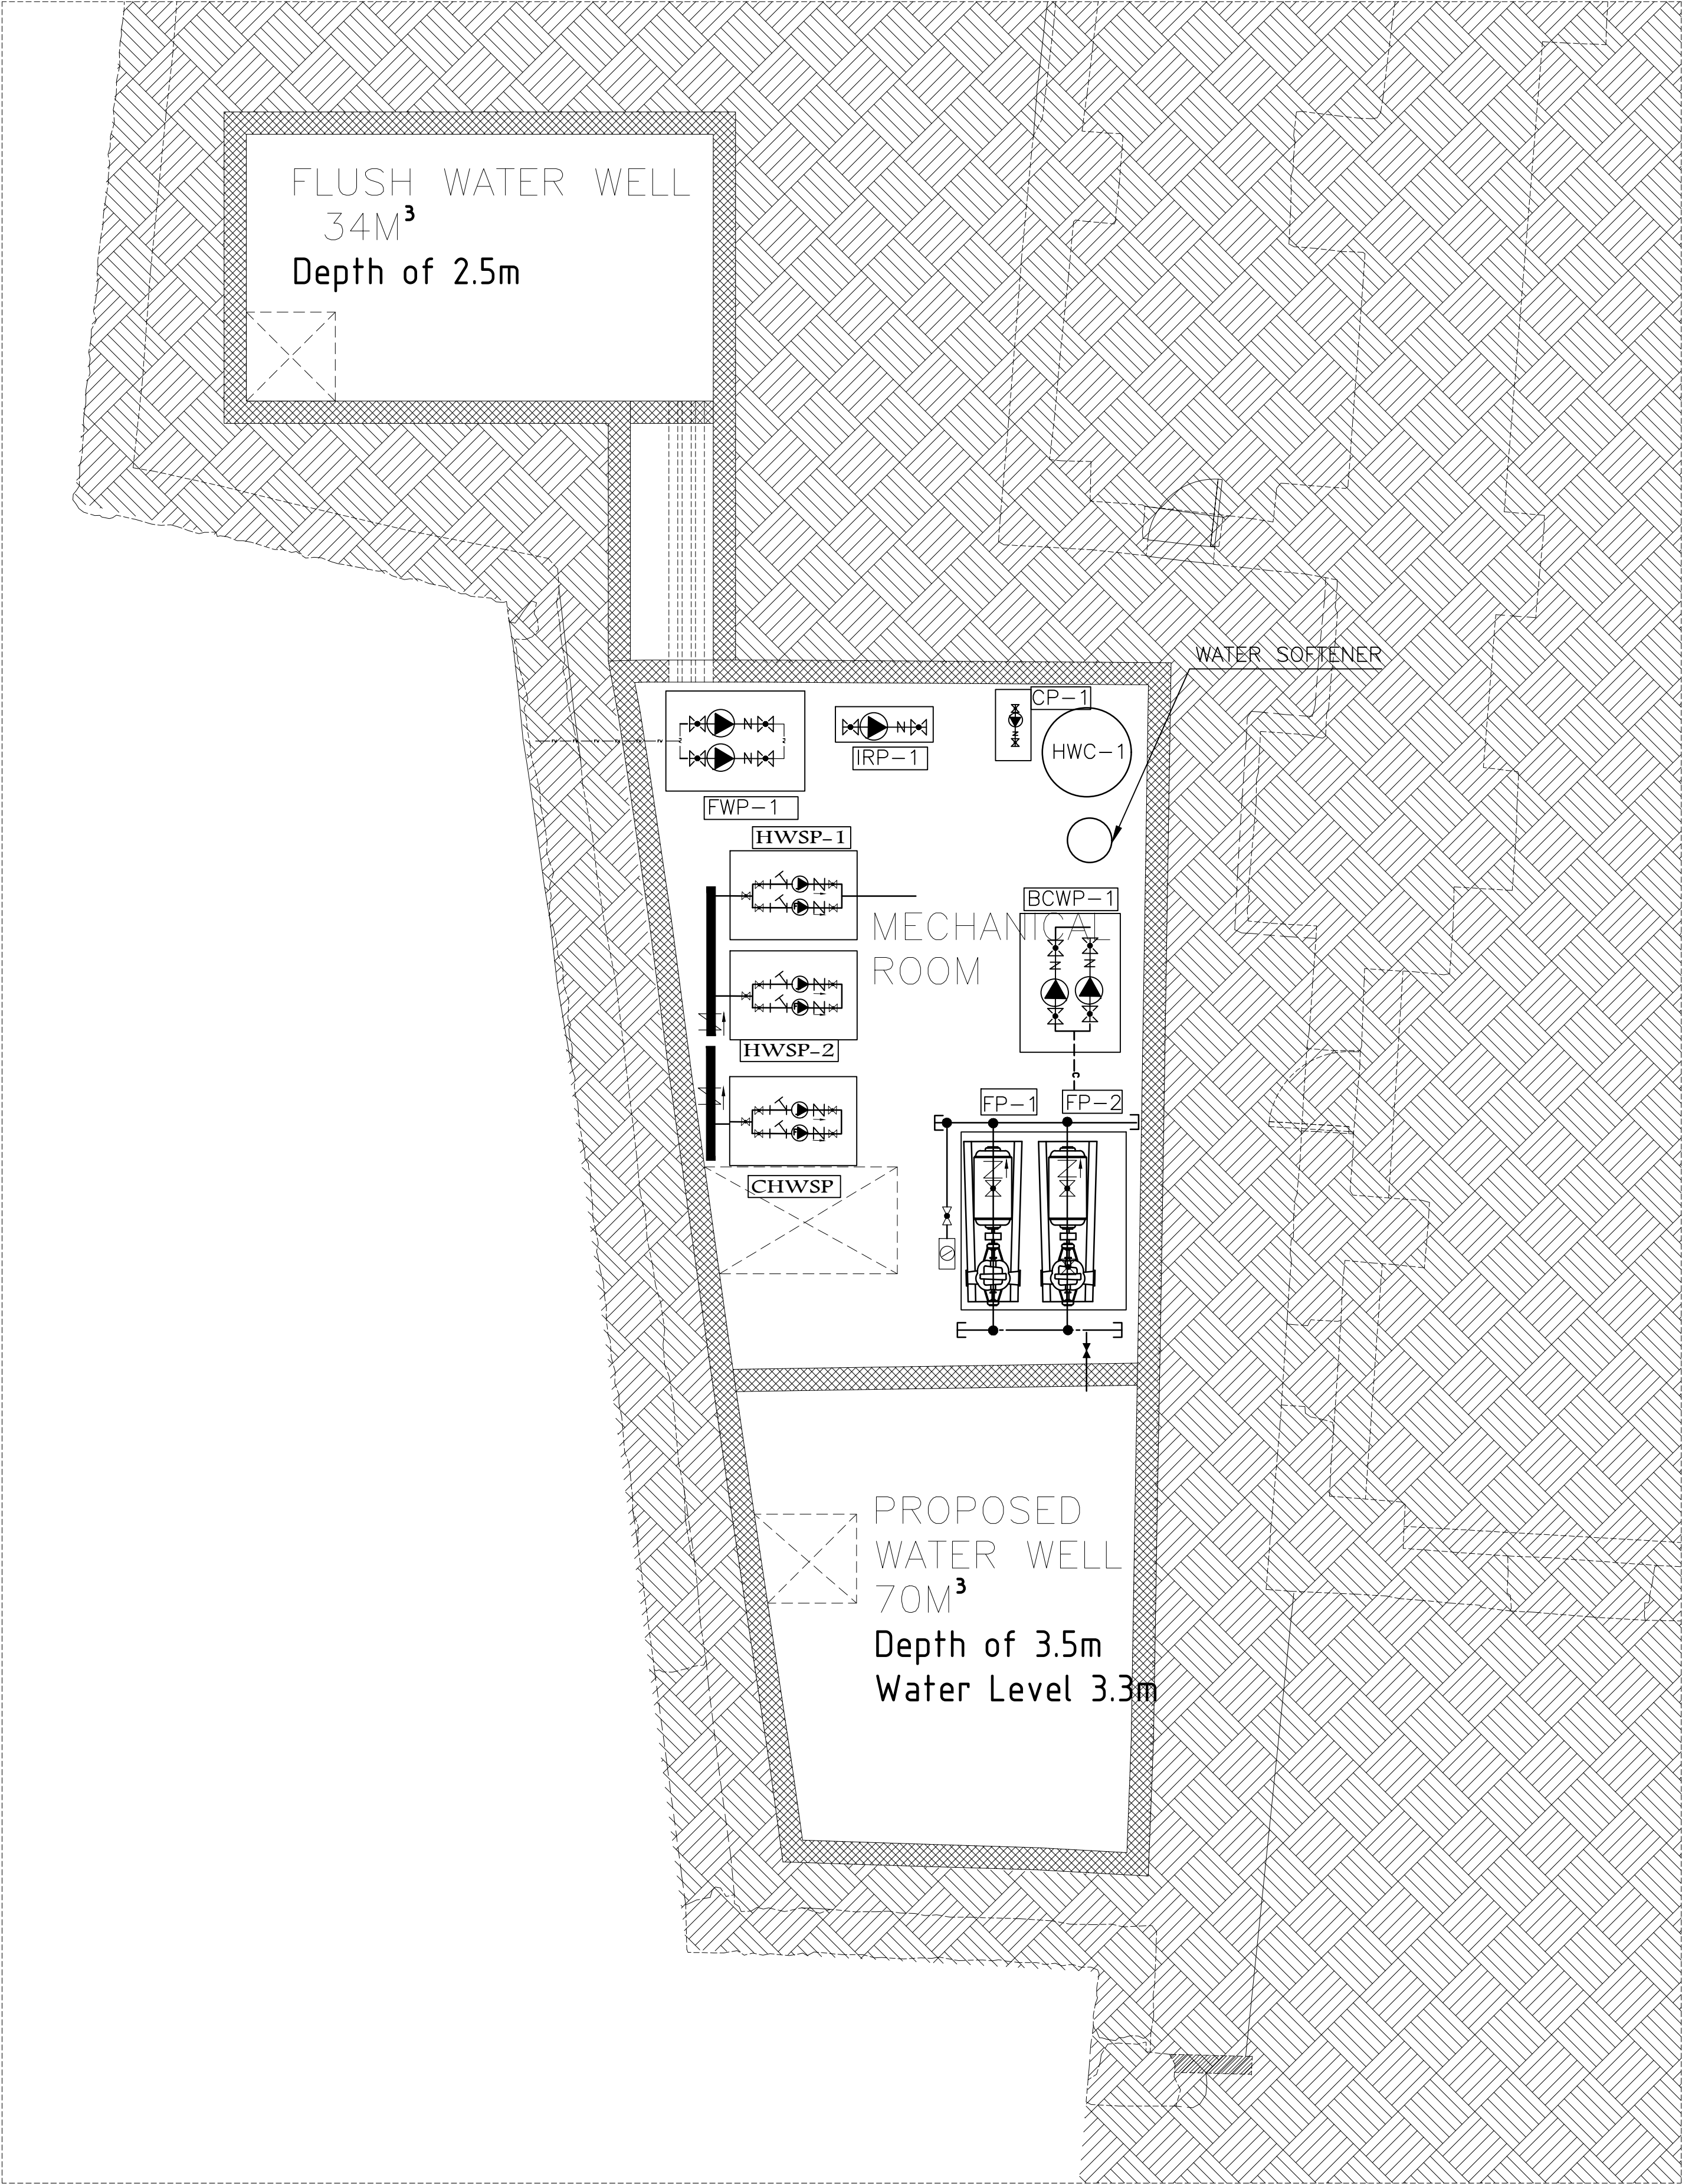

NOTES & LEGEND:

EUROPEAN UNION

UN
DP

50
YEARS

محافظة أريحا
Jericho Governorate

PROJECT:

Securing Professional Services for the Architectural Restoration and Rehabilitation Designs, Archaeological Documentation and Orientation Training, Including Tender Documents Preparation and Site Supervision for Conservation and Rehabilitation Works of Maqam Al-Nabi Musa in Jericho Governorate

Support to Development of Cultural Tourism

DESIGN WORKS:

Jerusalem Design Center

ELECTRICAL WORKS:

Eng. Midhat AlSharif

MECHANICAL WORKS:

Elite Mechanical Consultants

SHEET NAME:

PUMP ROOM
EQUIPMENT LAYOUT

SCALE: 1 : 50
(IF PILOTTED ON A3)

EDITION: MECHANICAL

☐ For Review
☐ For Approval
☒ For Tender
☐ For Construction

SHEET NO.

Jerusalem Design Center
Architects, Engineers & Consultants

Phone: 02 234 3696 | Fax: 02 234 3719 | Email: info@jdc.ps



Securing Professional Services for the Architectural Restoration and Rehabilitation Designs, Archaeological Documentation and Orientation Training, Including Tender Documents Preparation and Site Supervision for Conservation and Rehabilitation Works of Maqam Al-Nabi Musa in Jericho Governorate

Support to Development of Cultural Tourism

 -Jerusalem Design Center

-Eng .Midhat AlSharif


-Elite Mechanical Consultants



SEWAGE COLLECTION
PIT DETAIL










SCALE: N.T.S. EDITION: MECHANICAL

☐ For Approval
☒ For Tender
☐ For Construction




jdc **JerusalemDesignCenter**
Architects, Engineers & Consultants

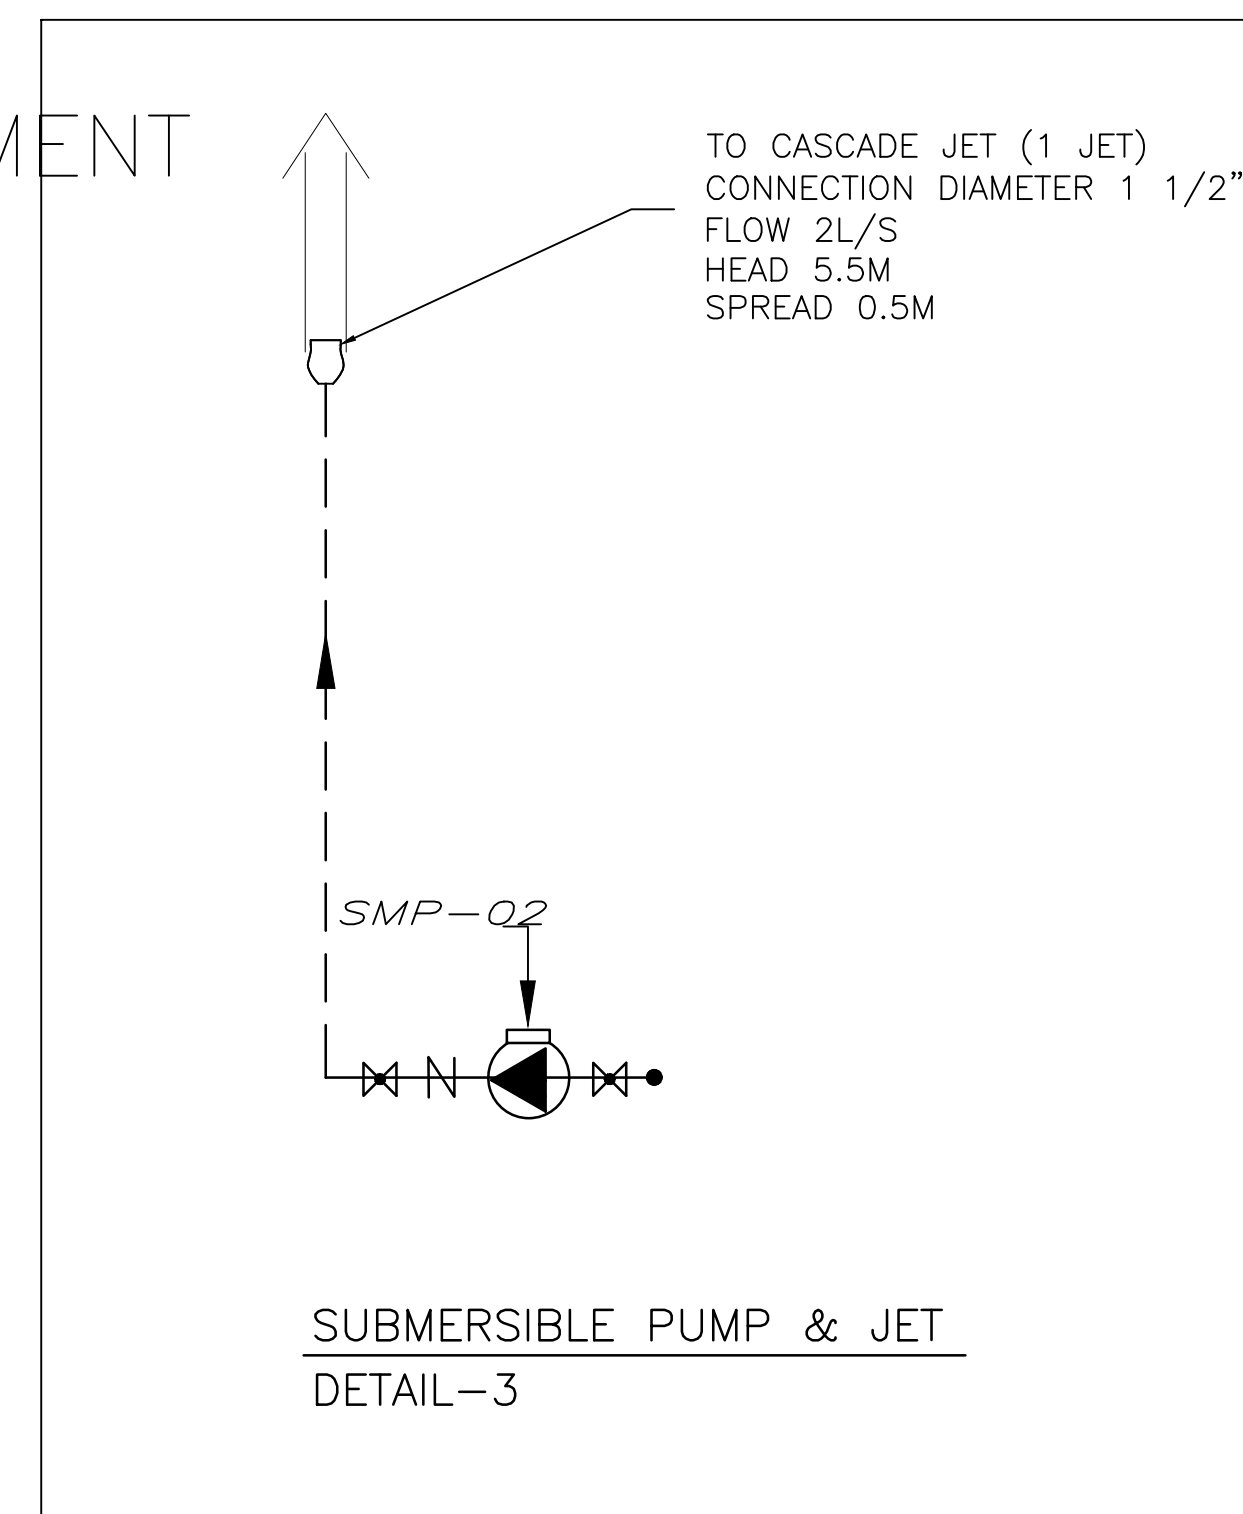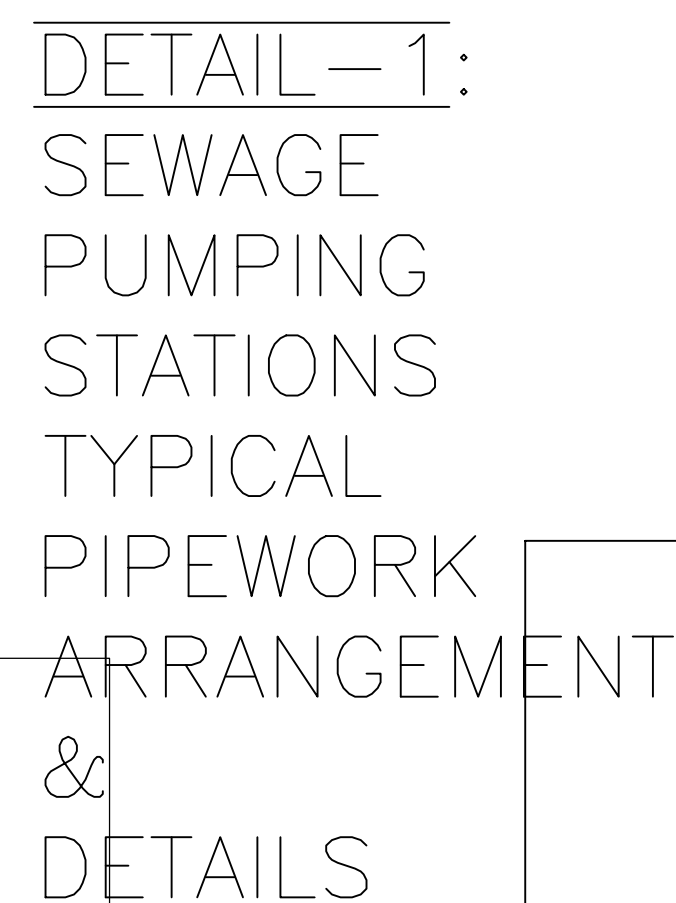

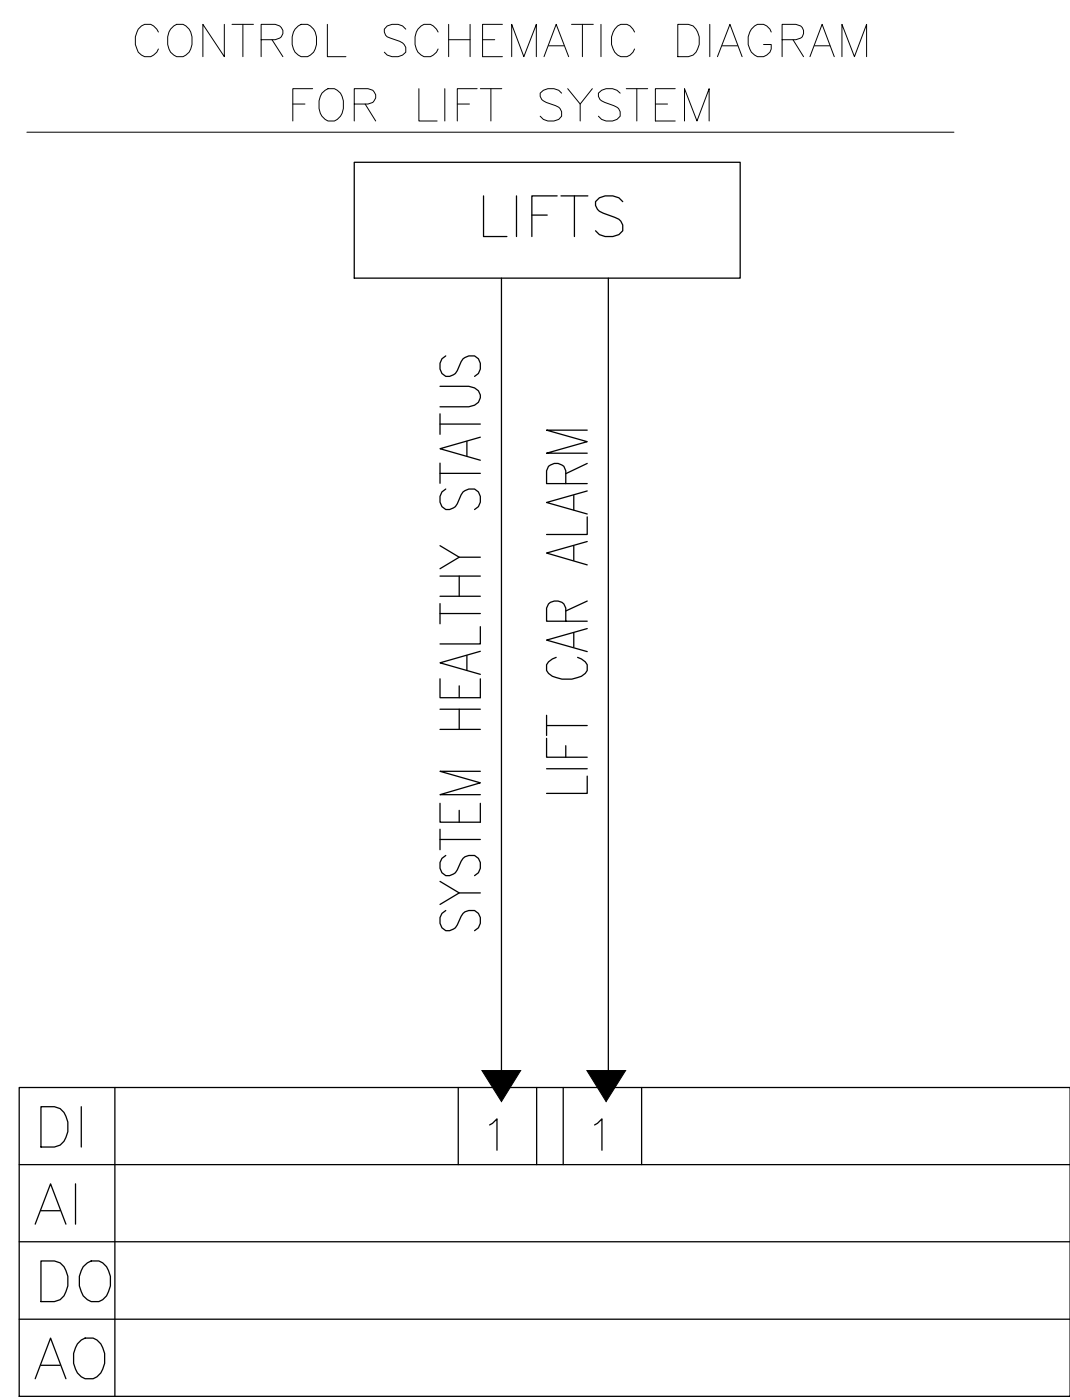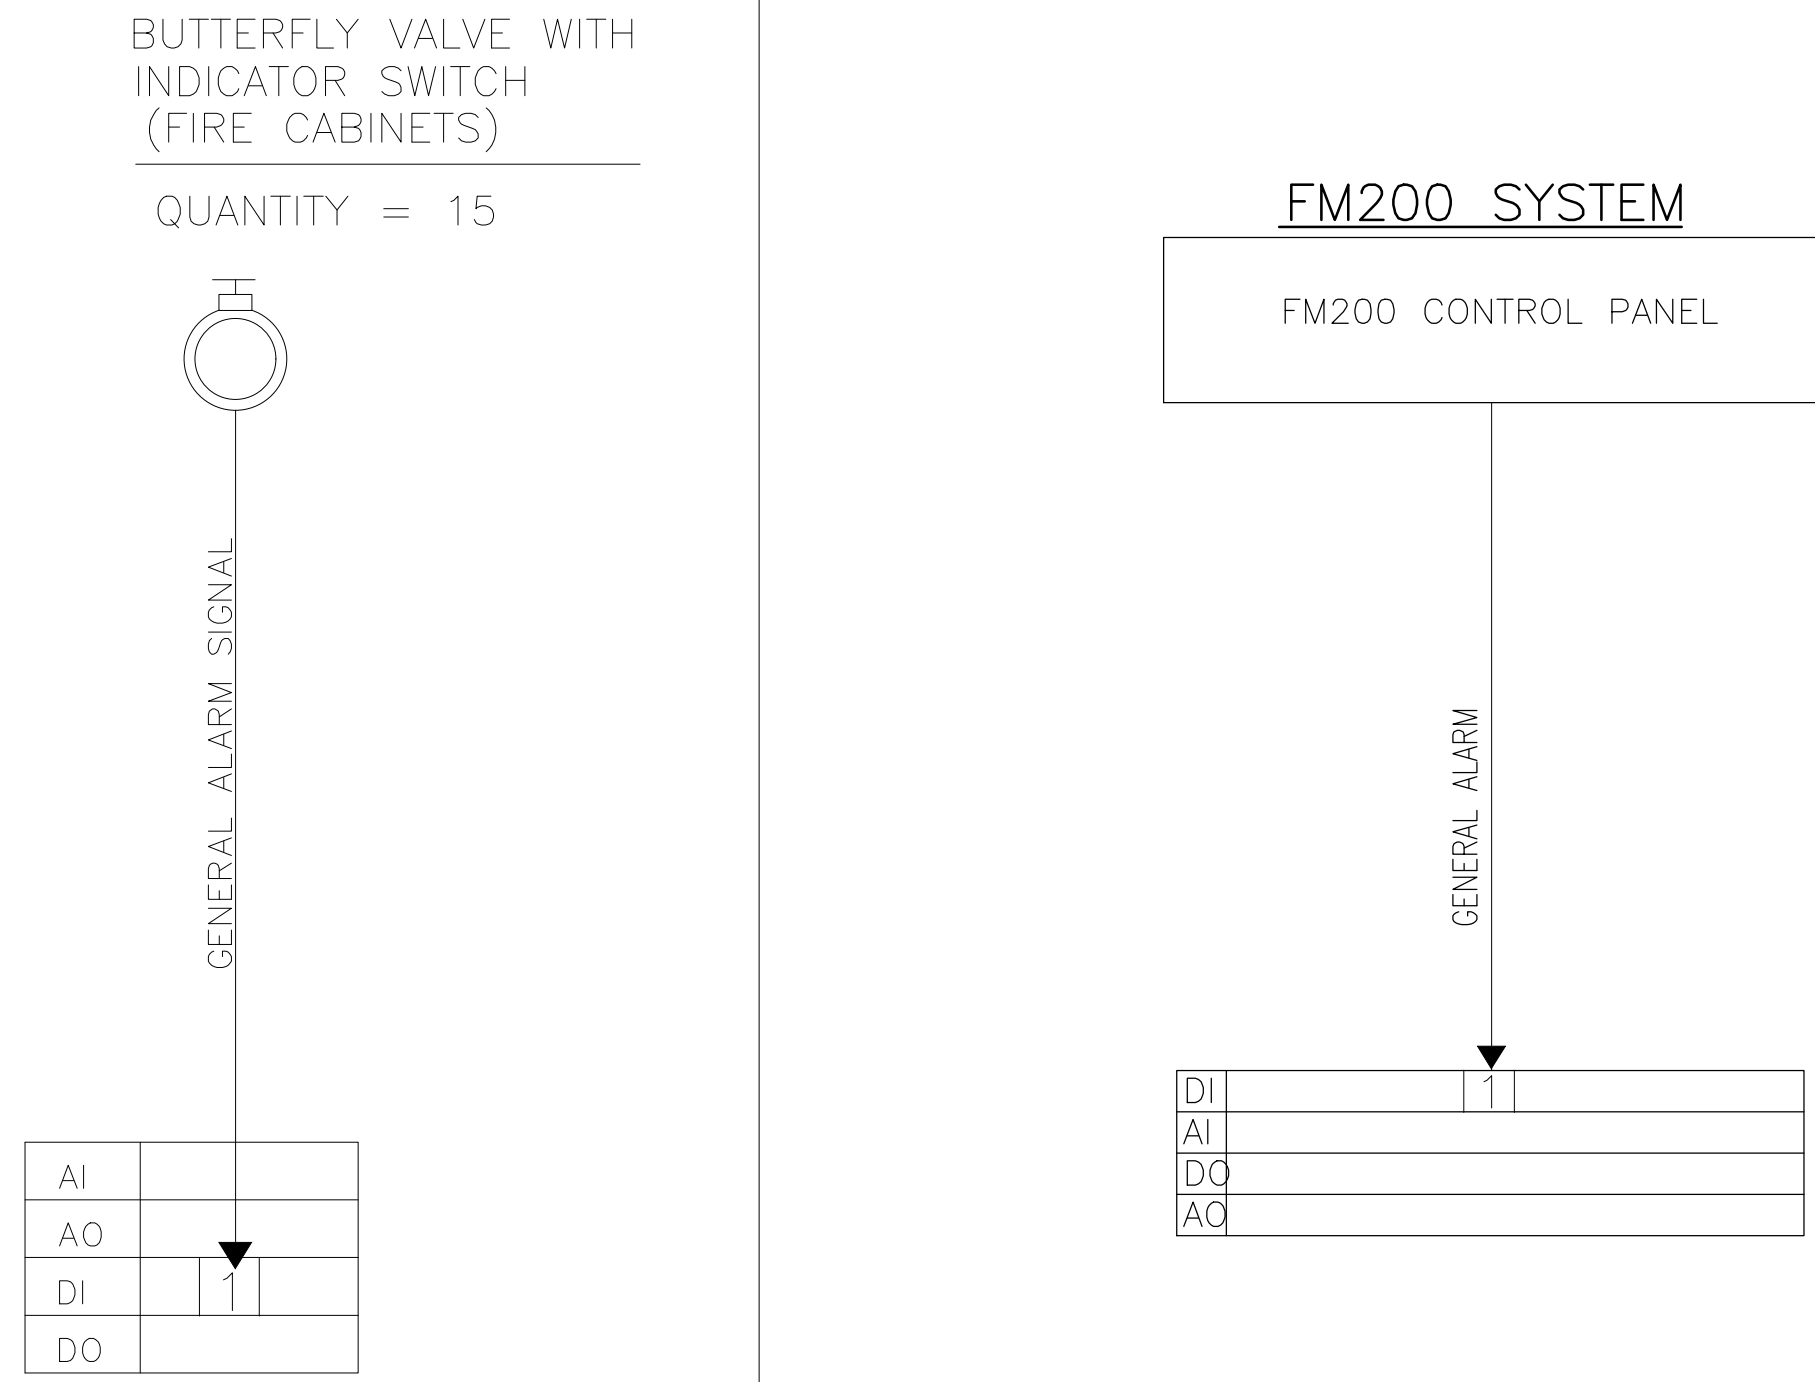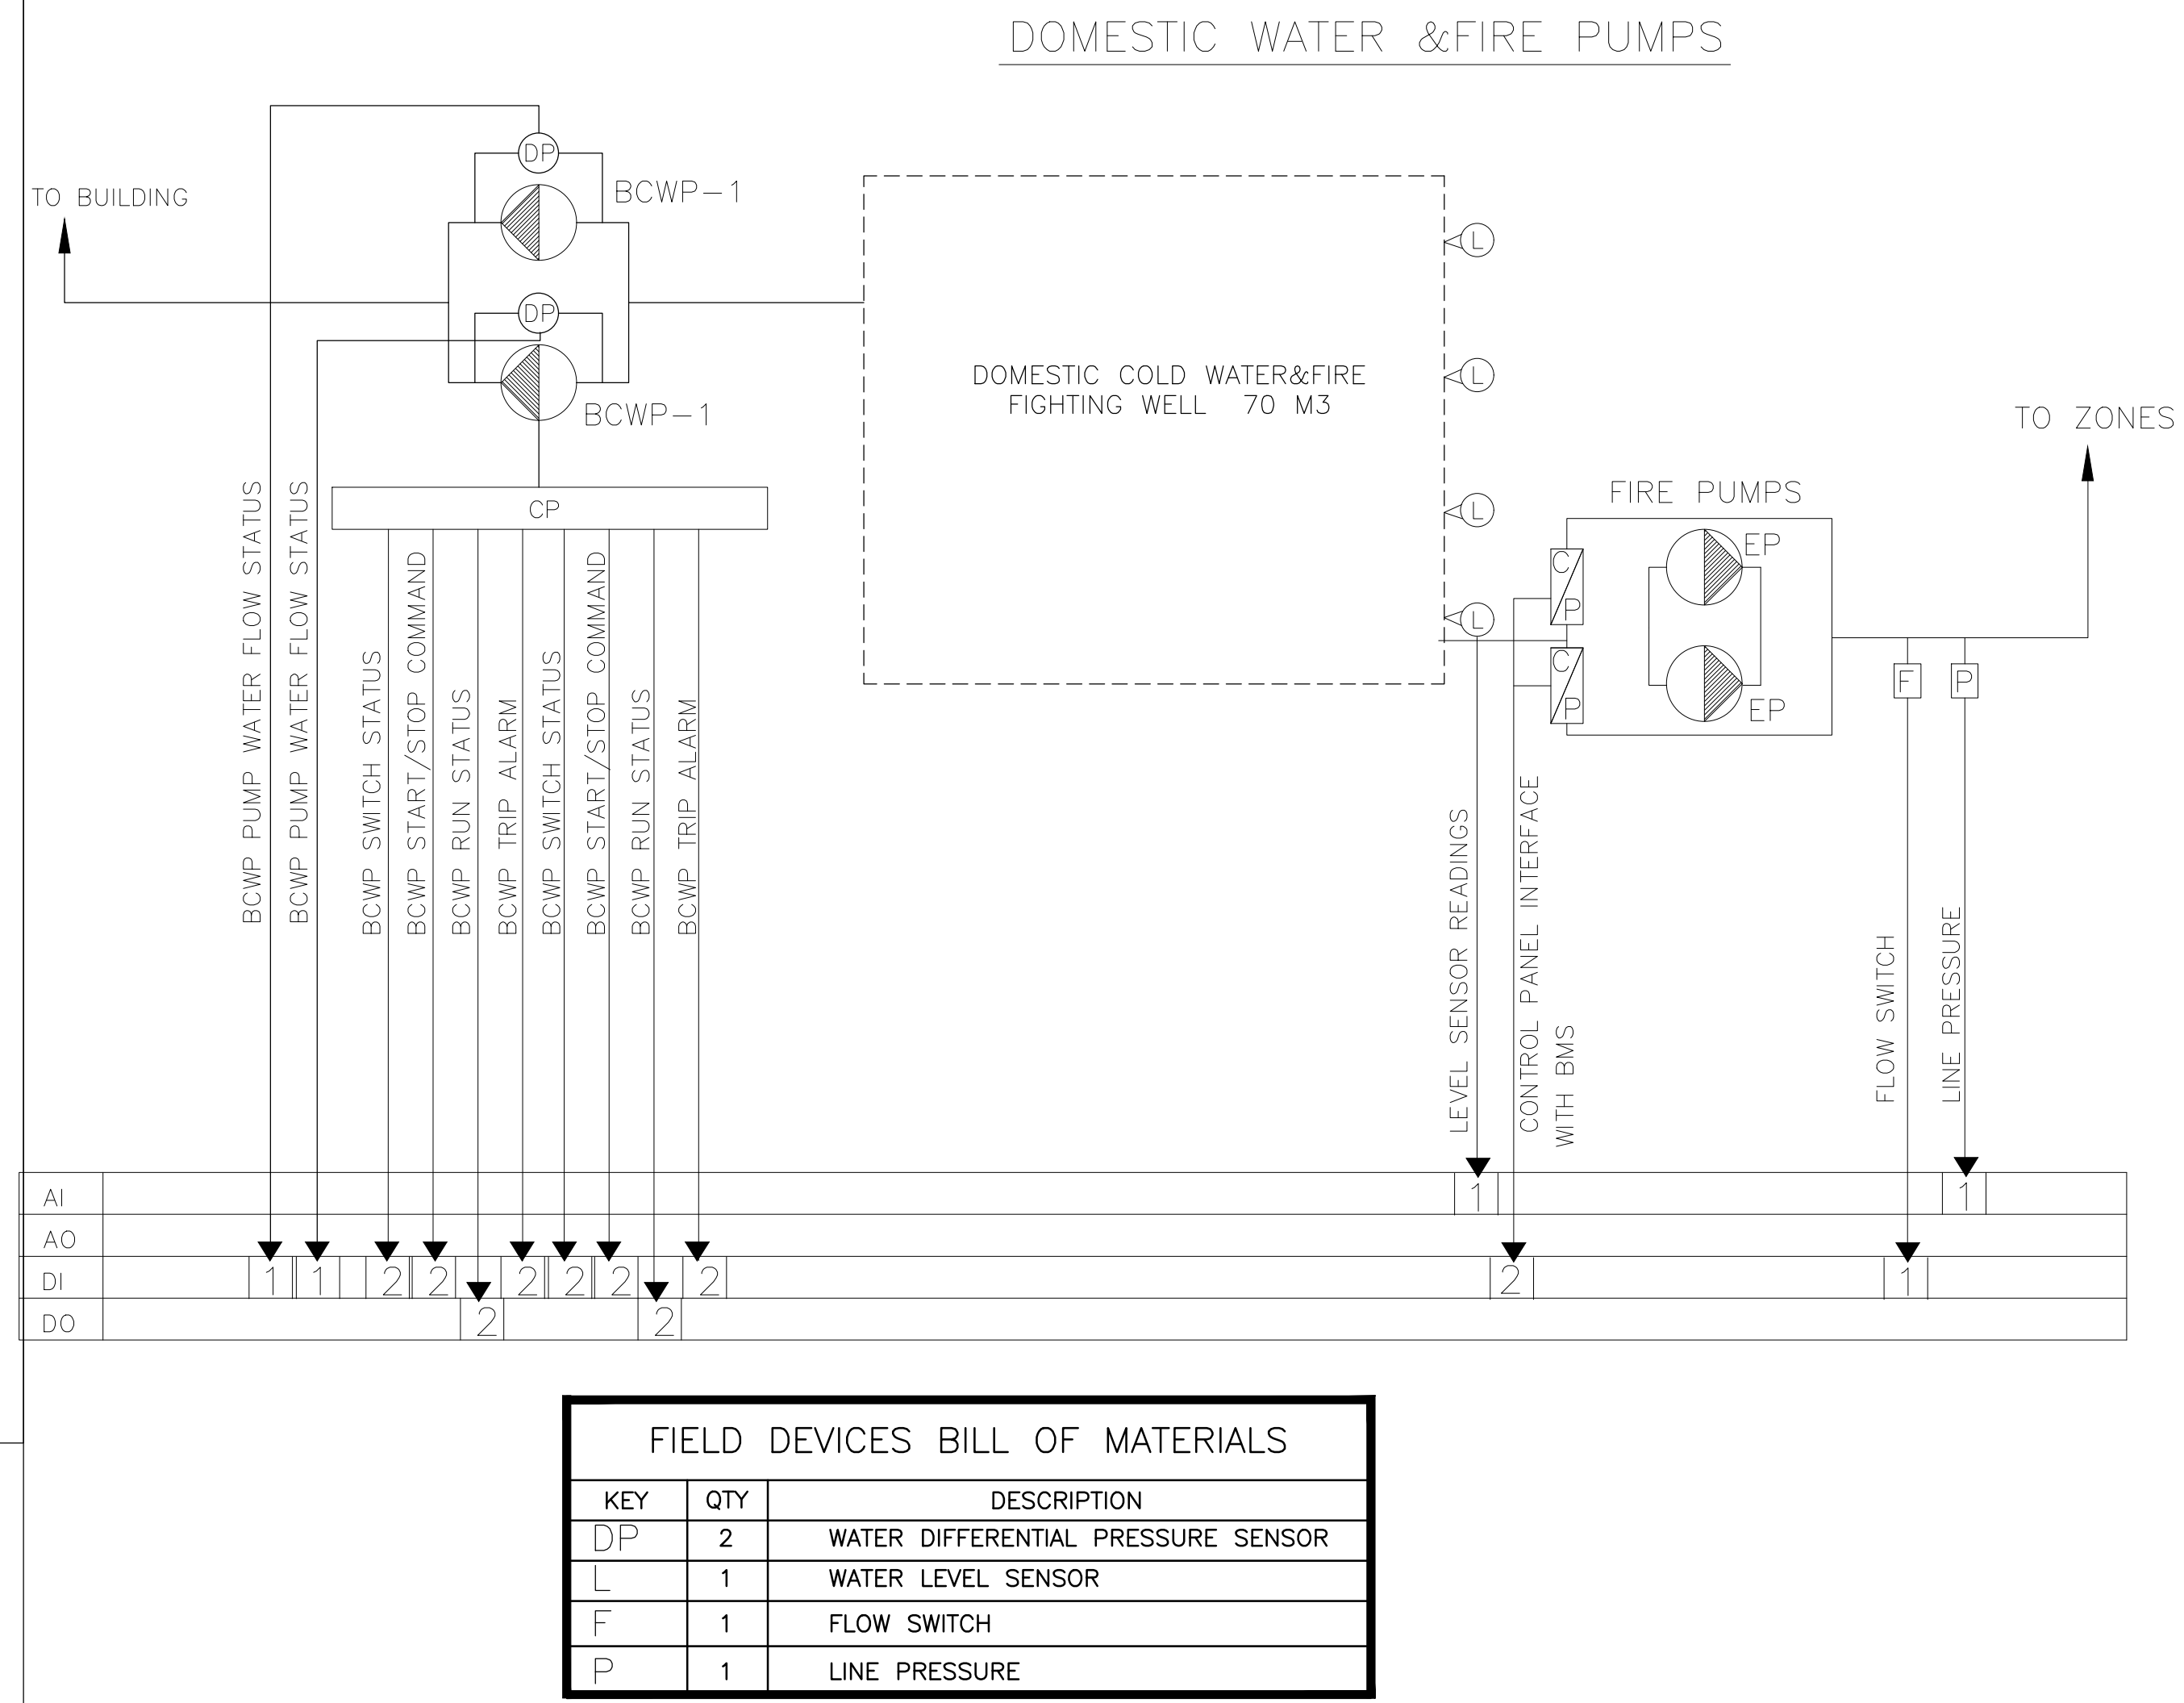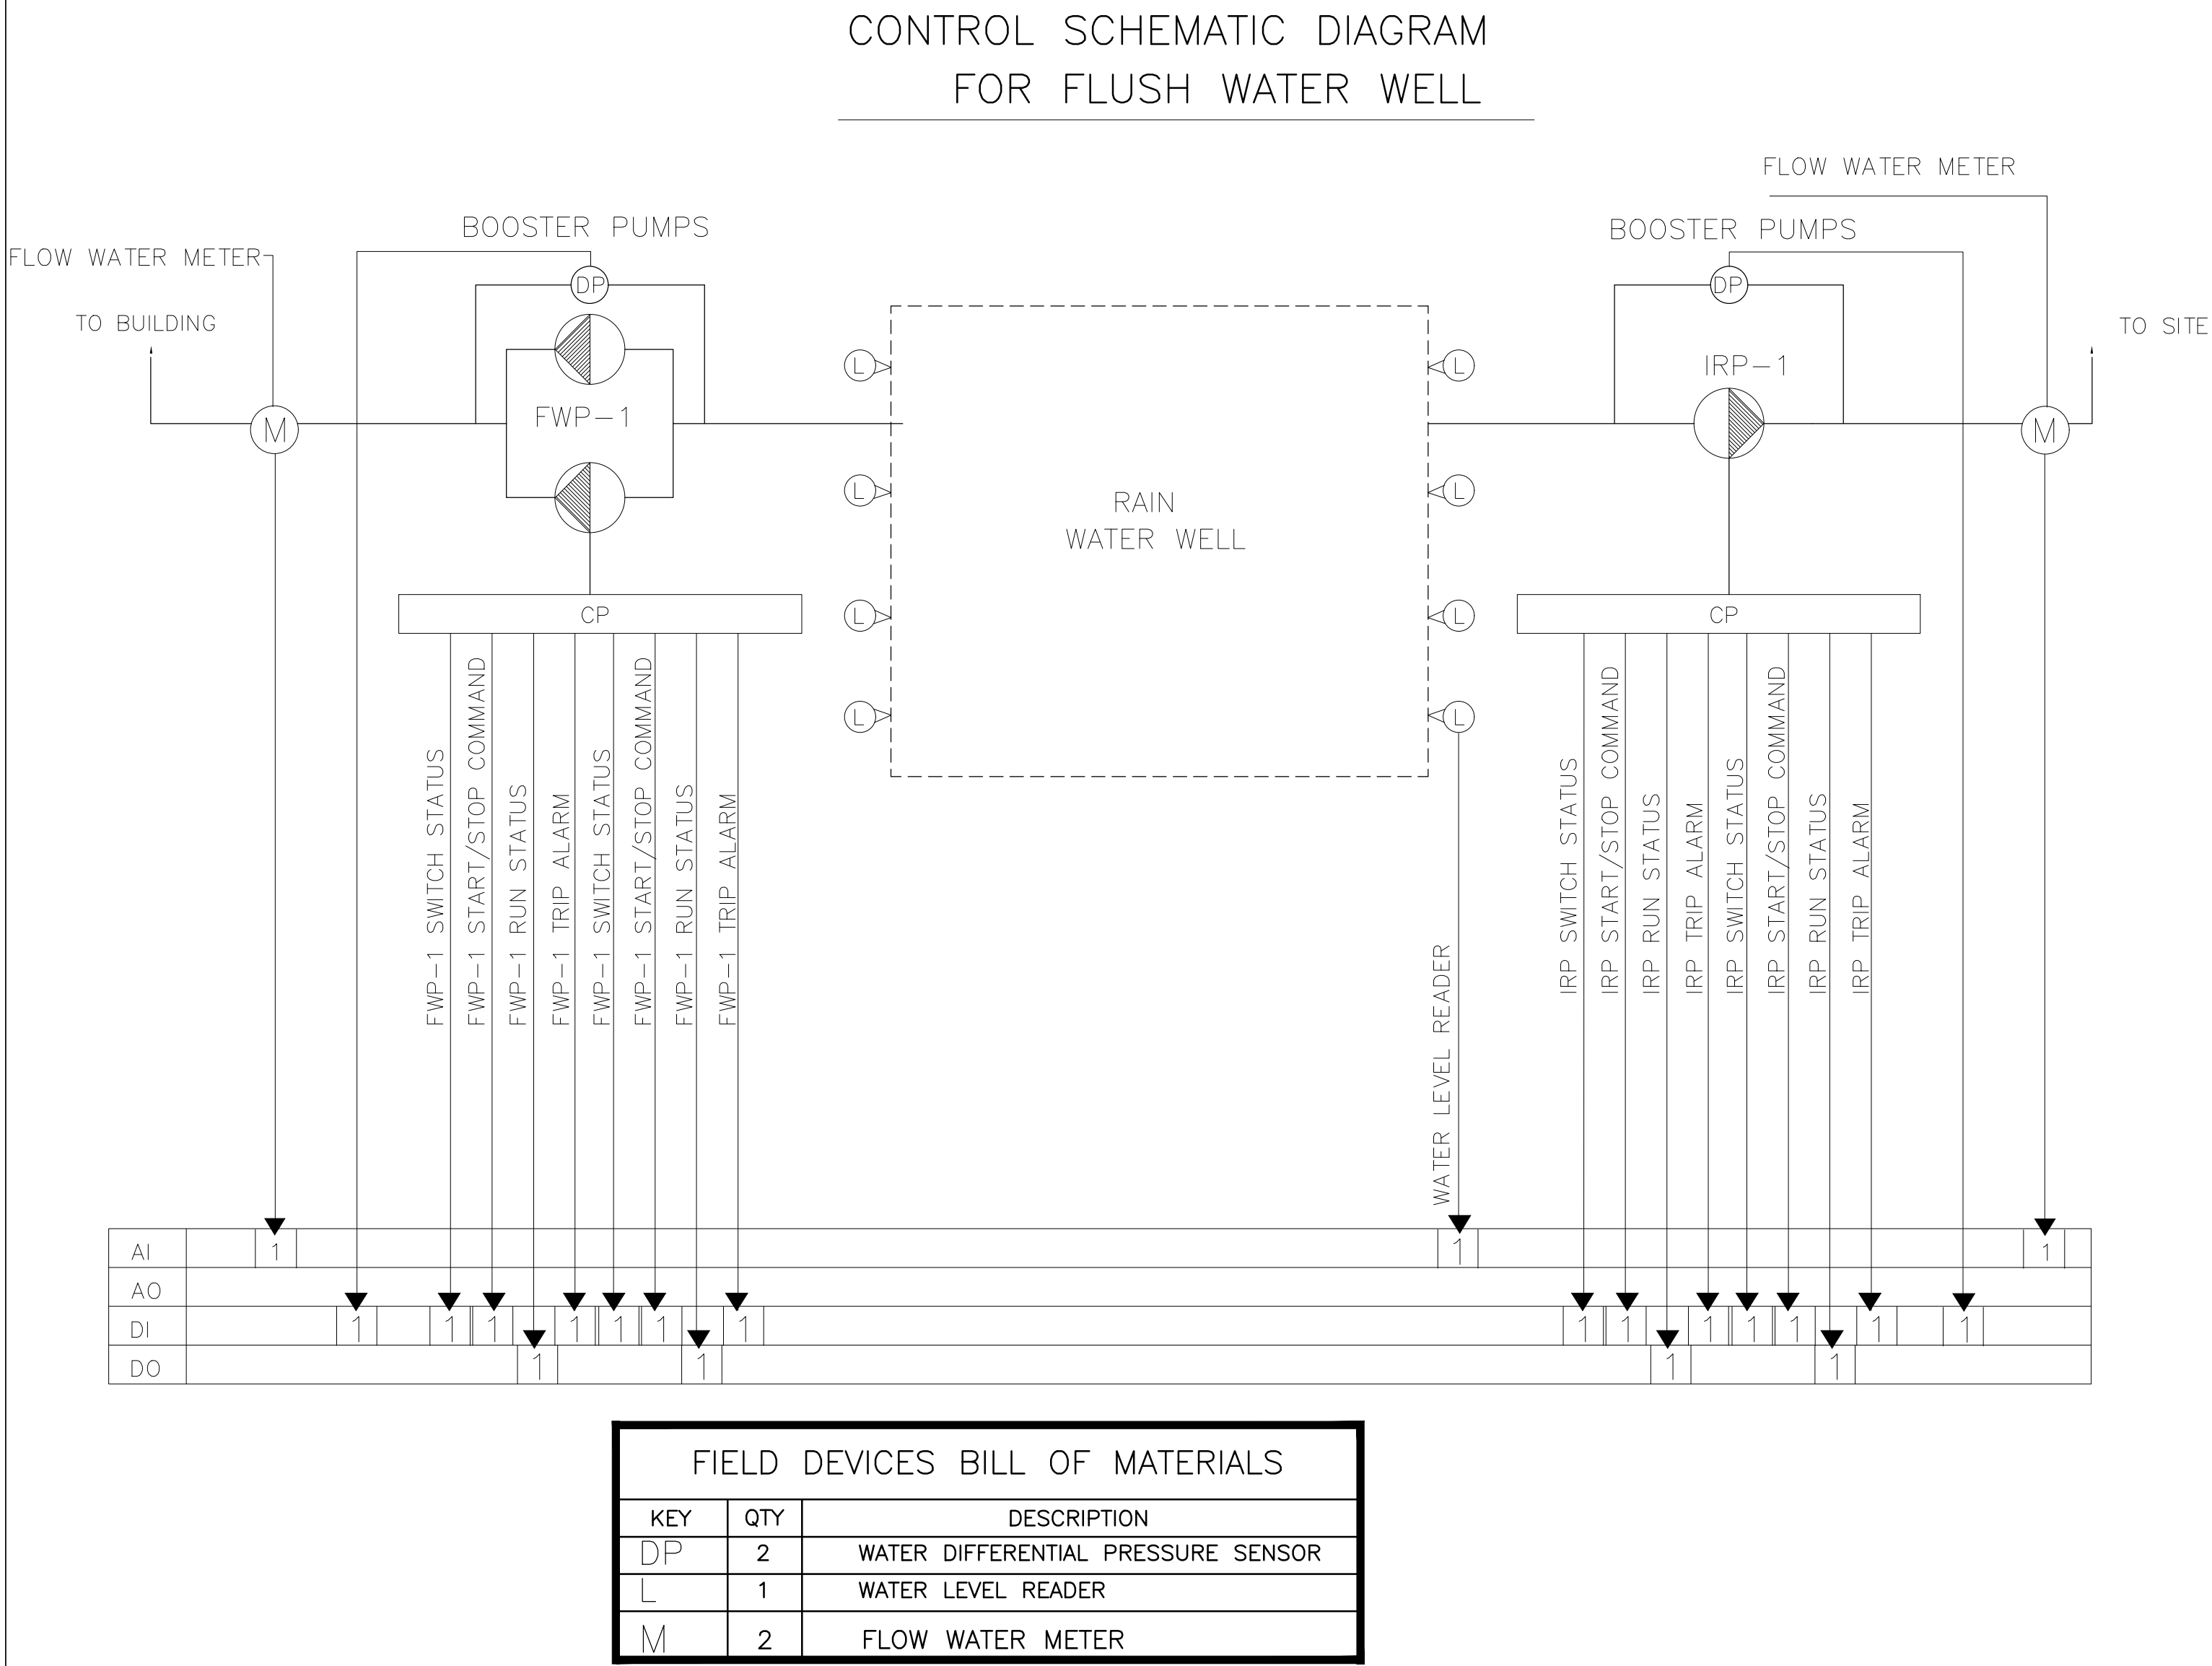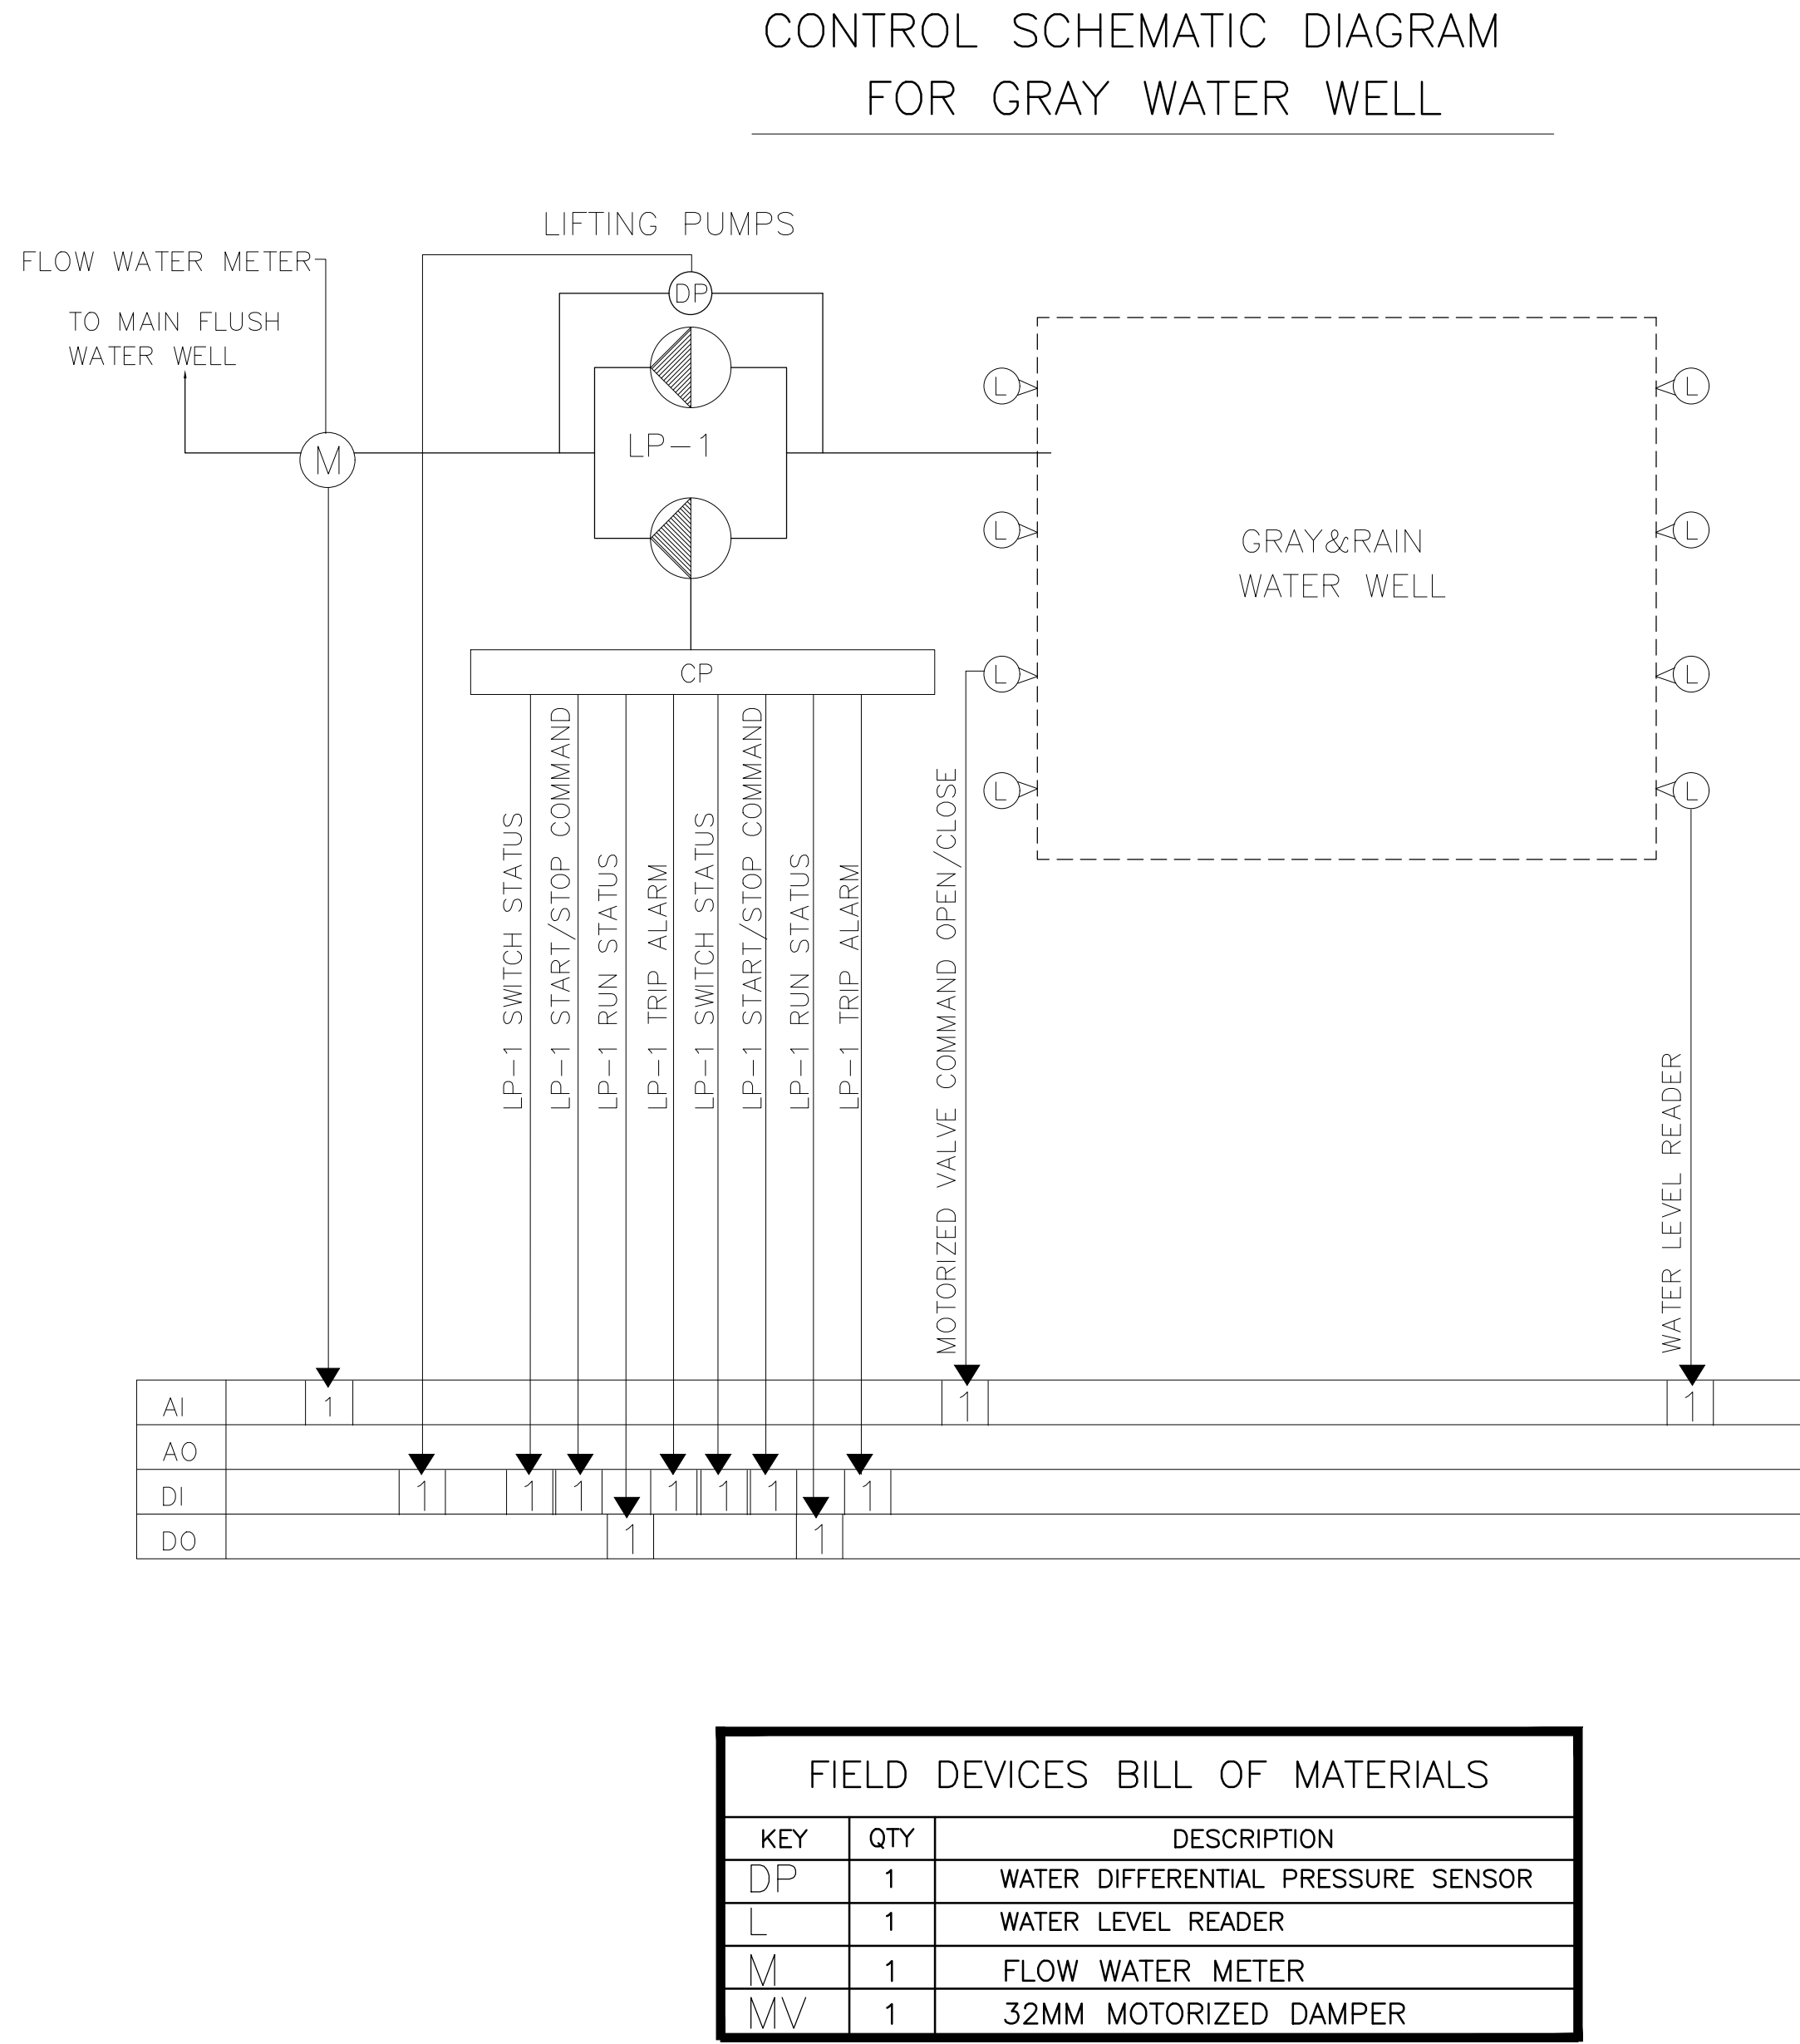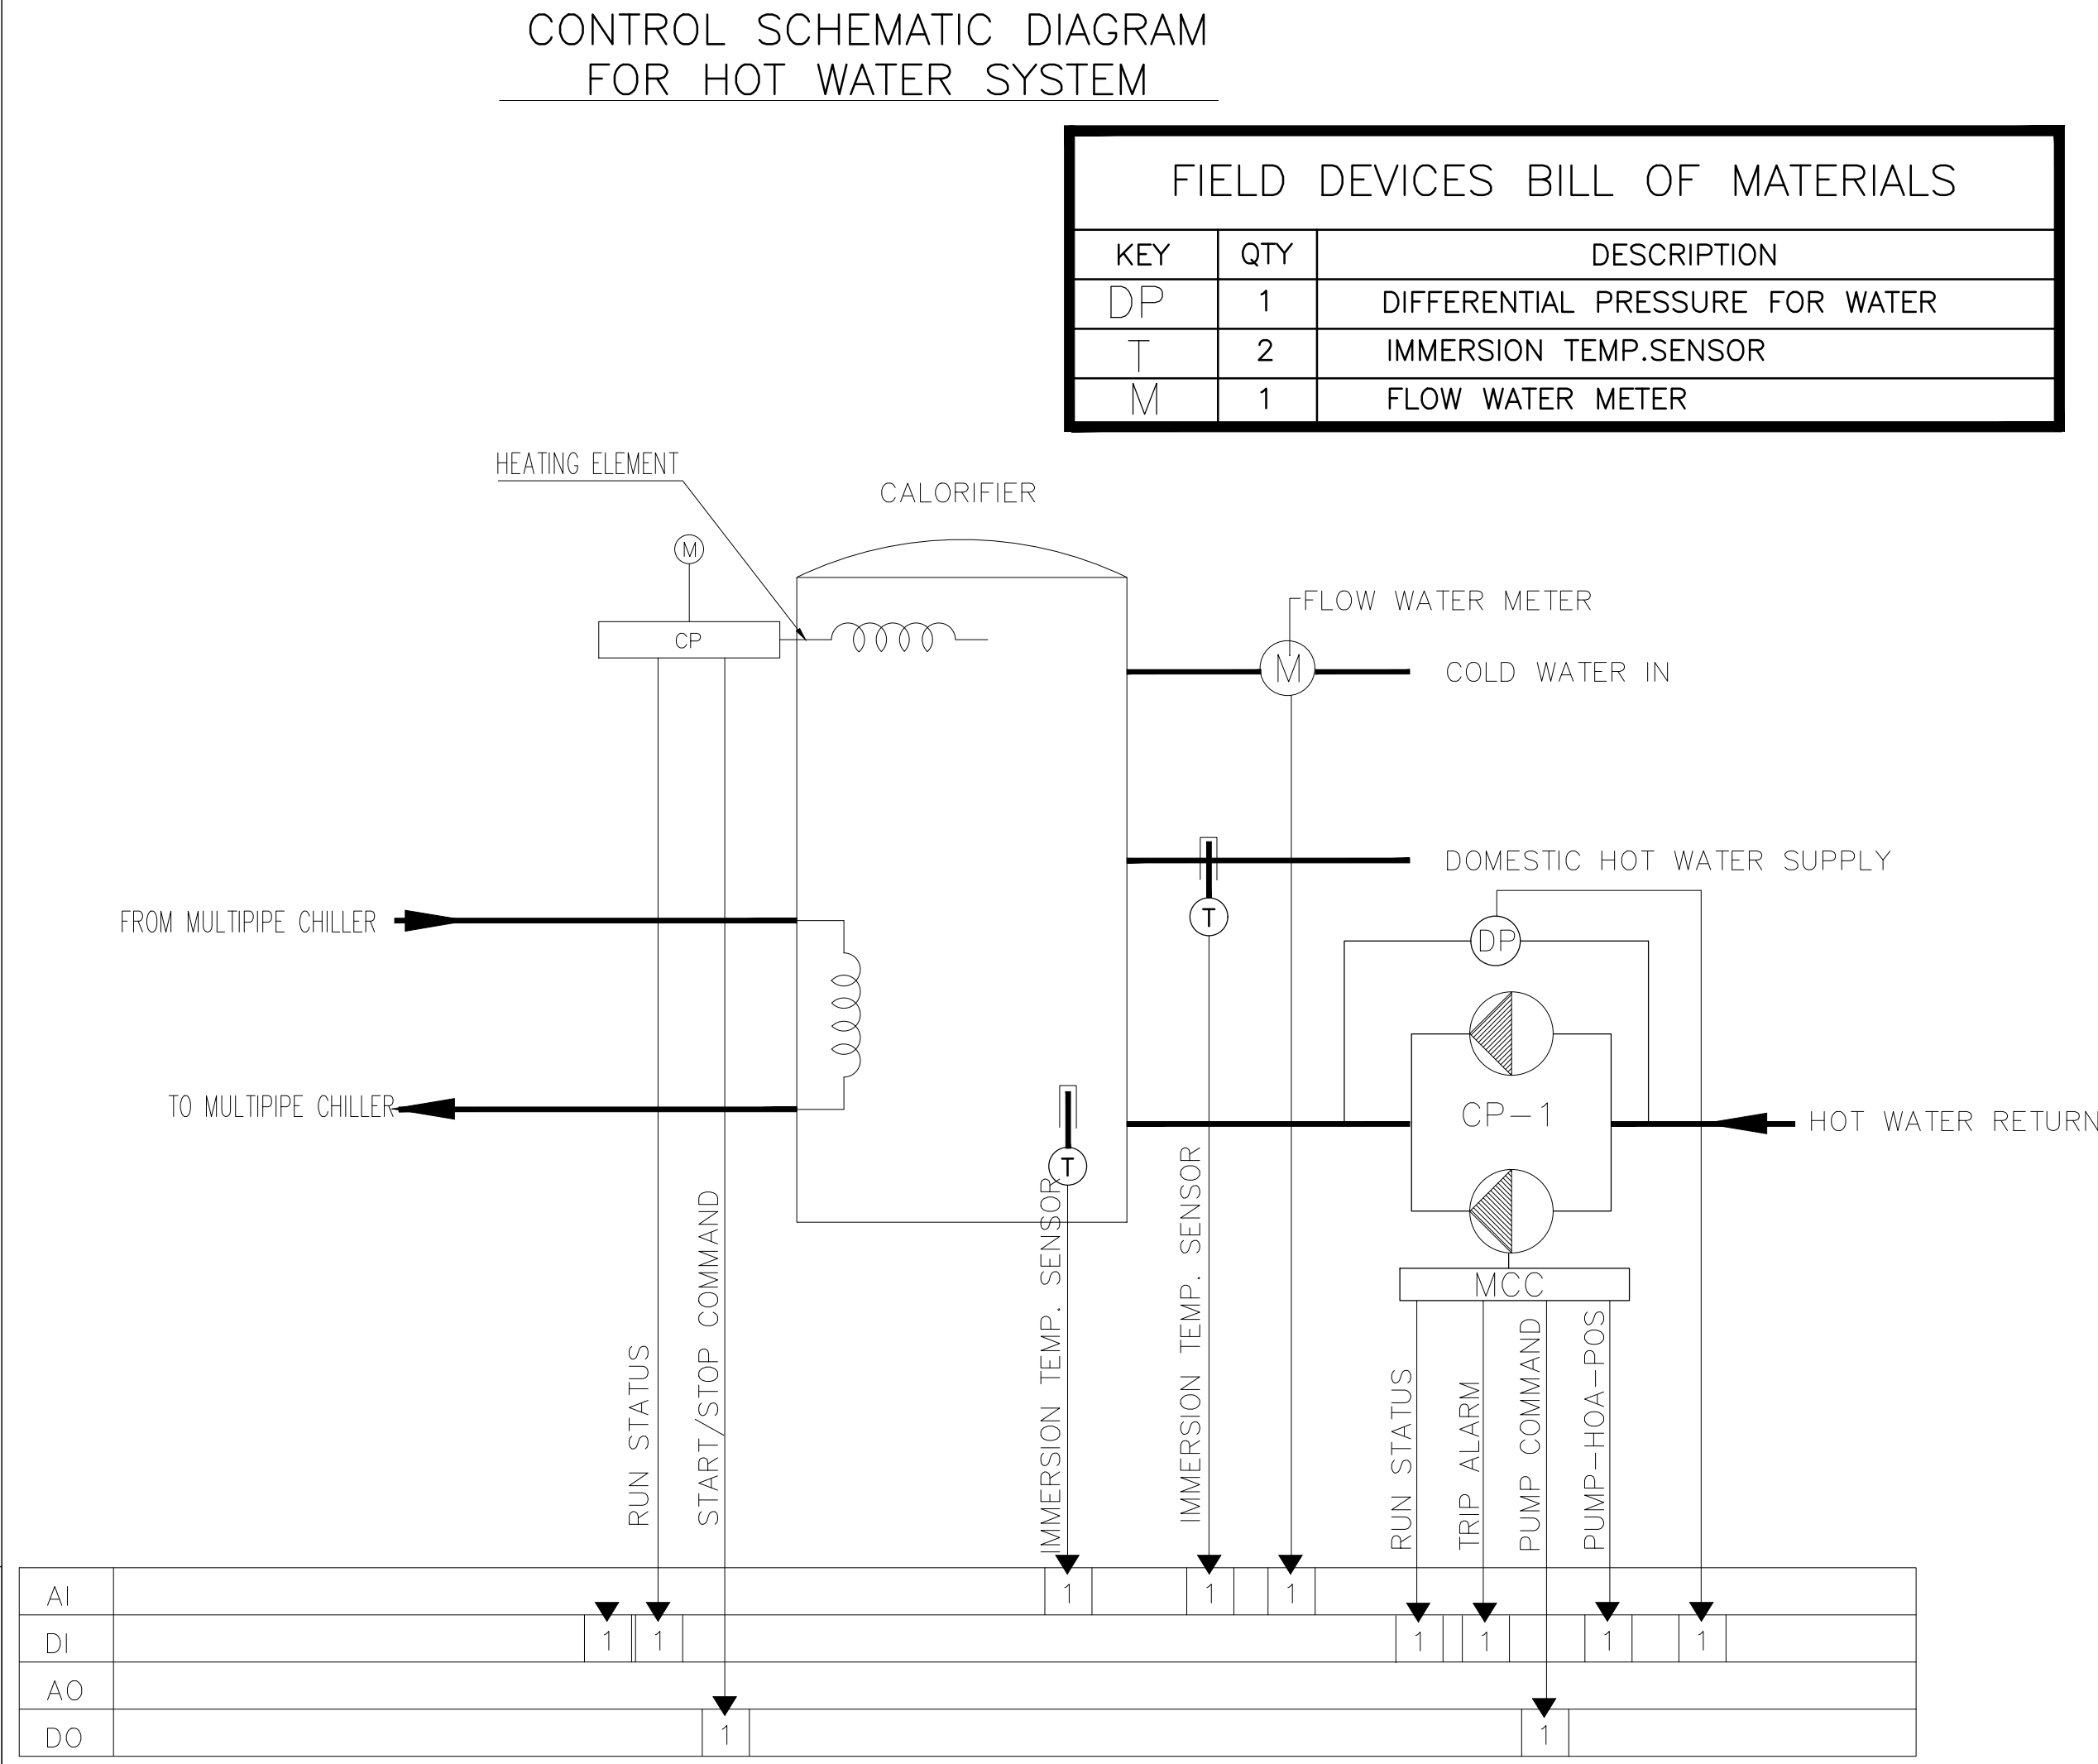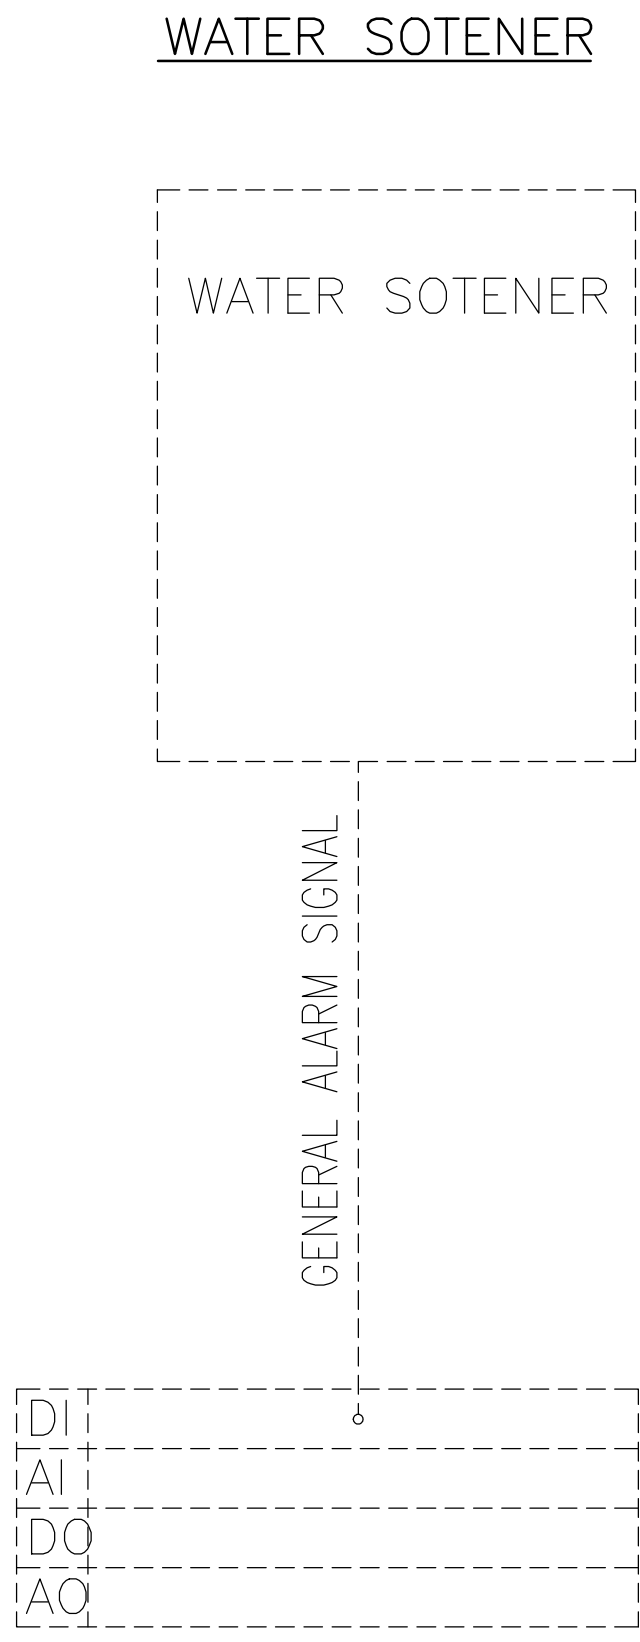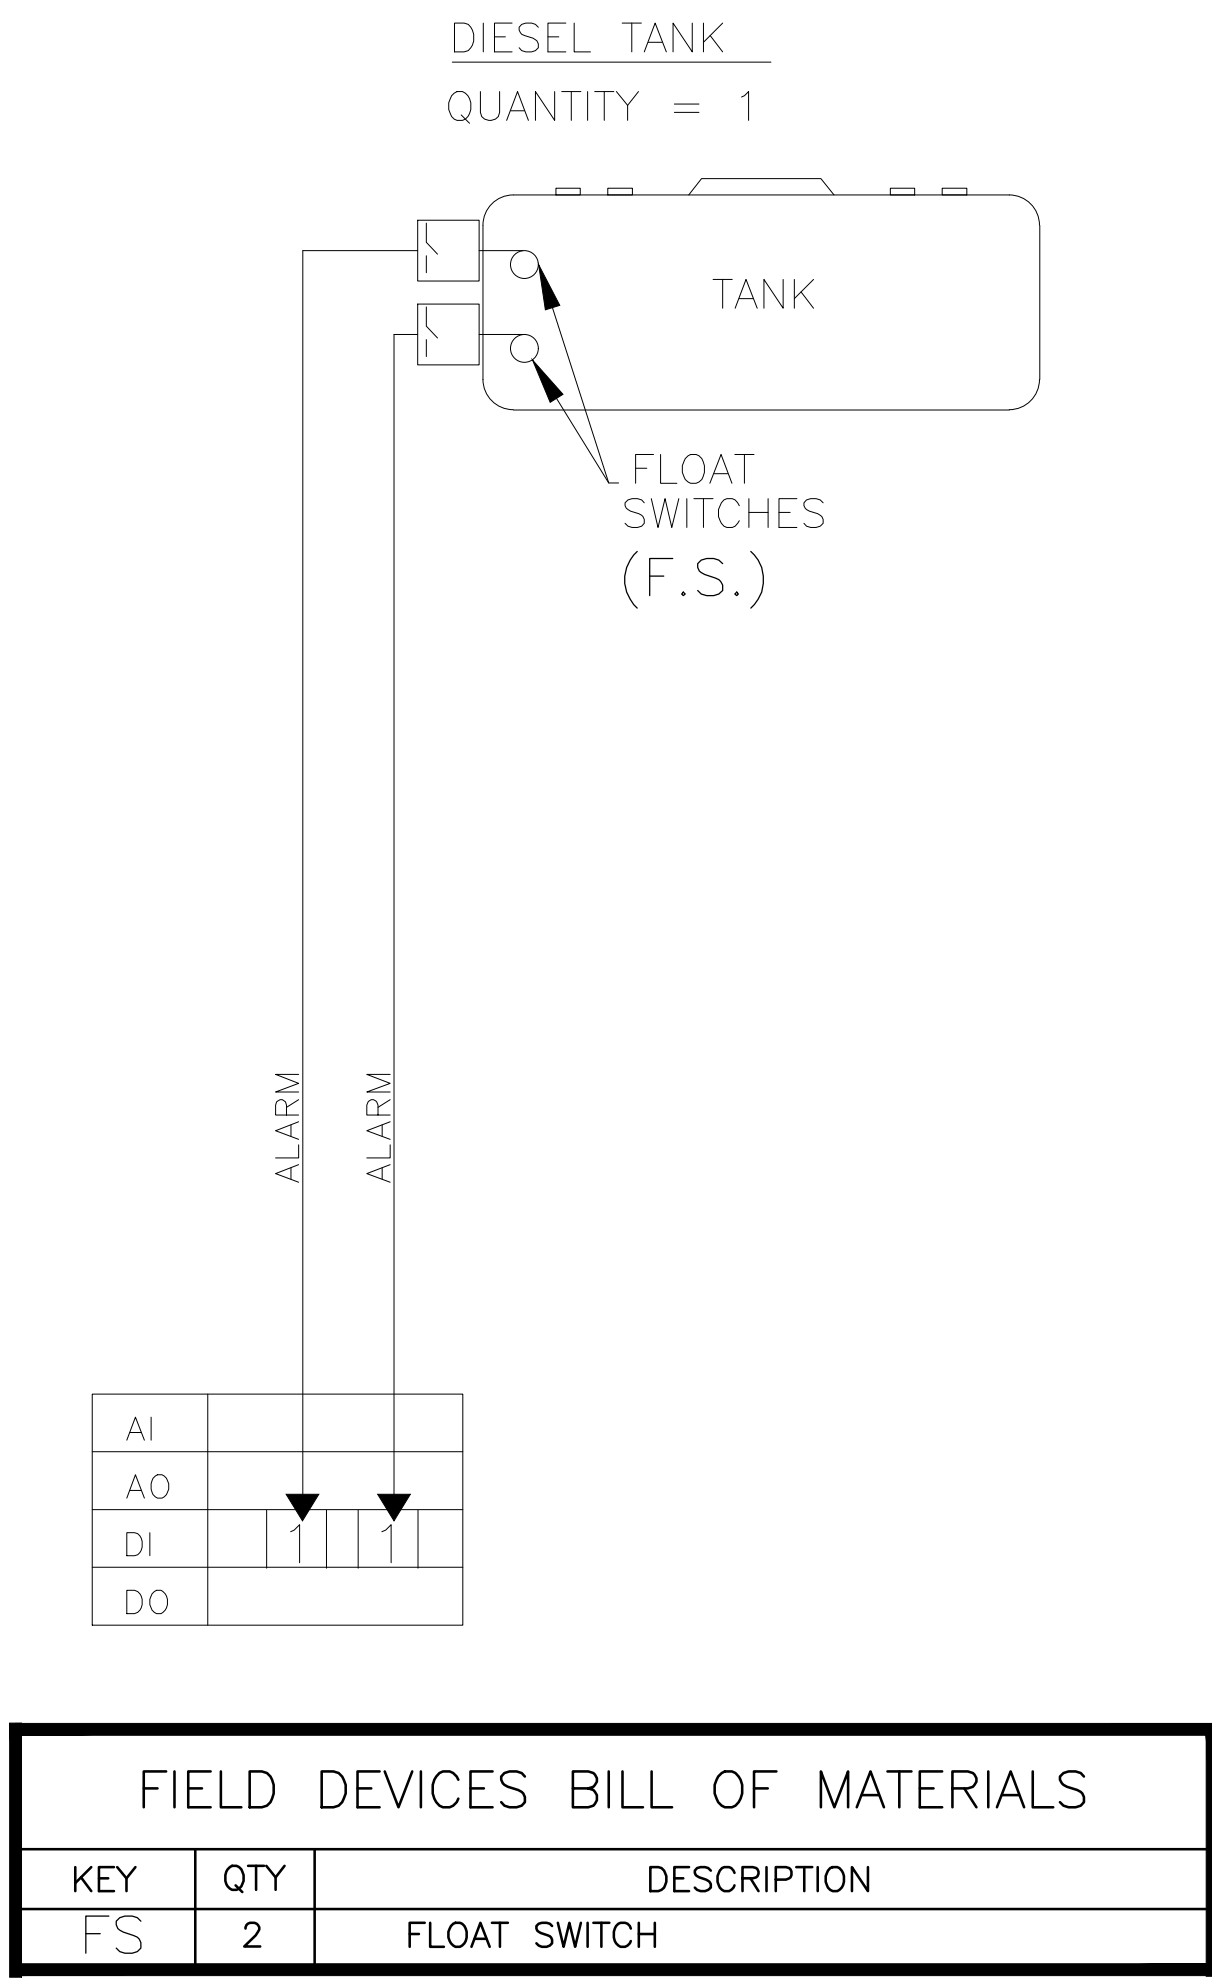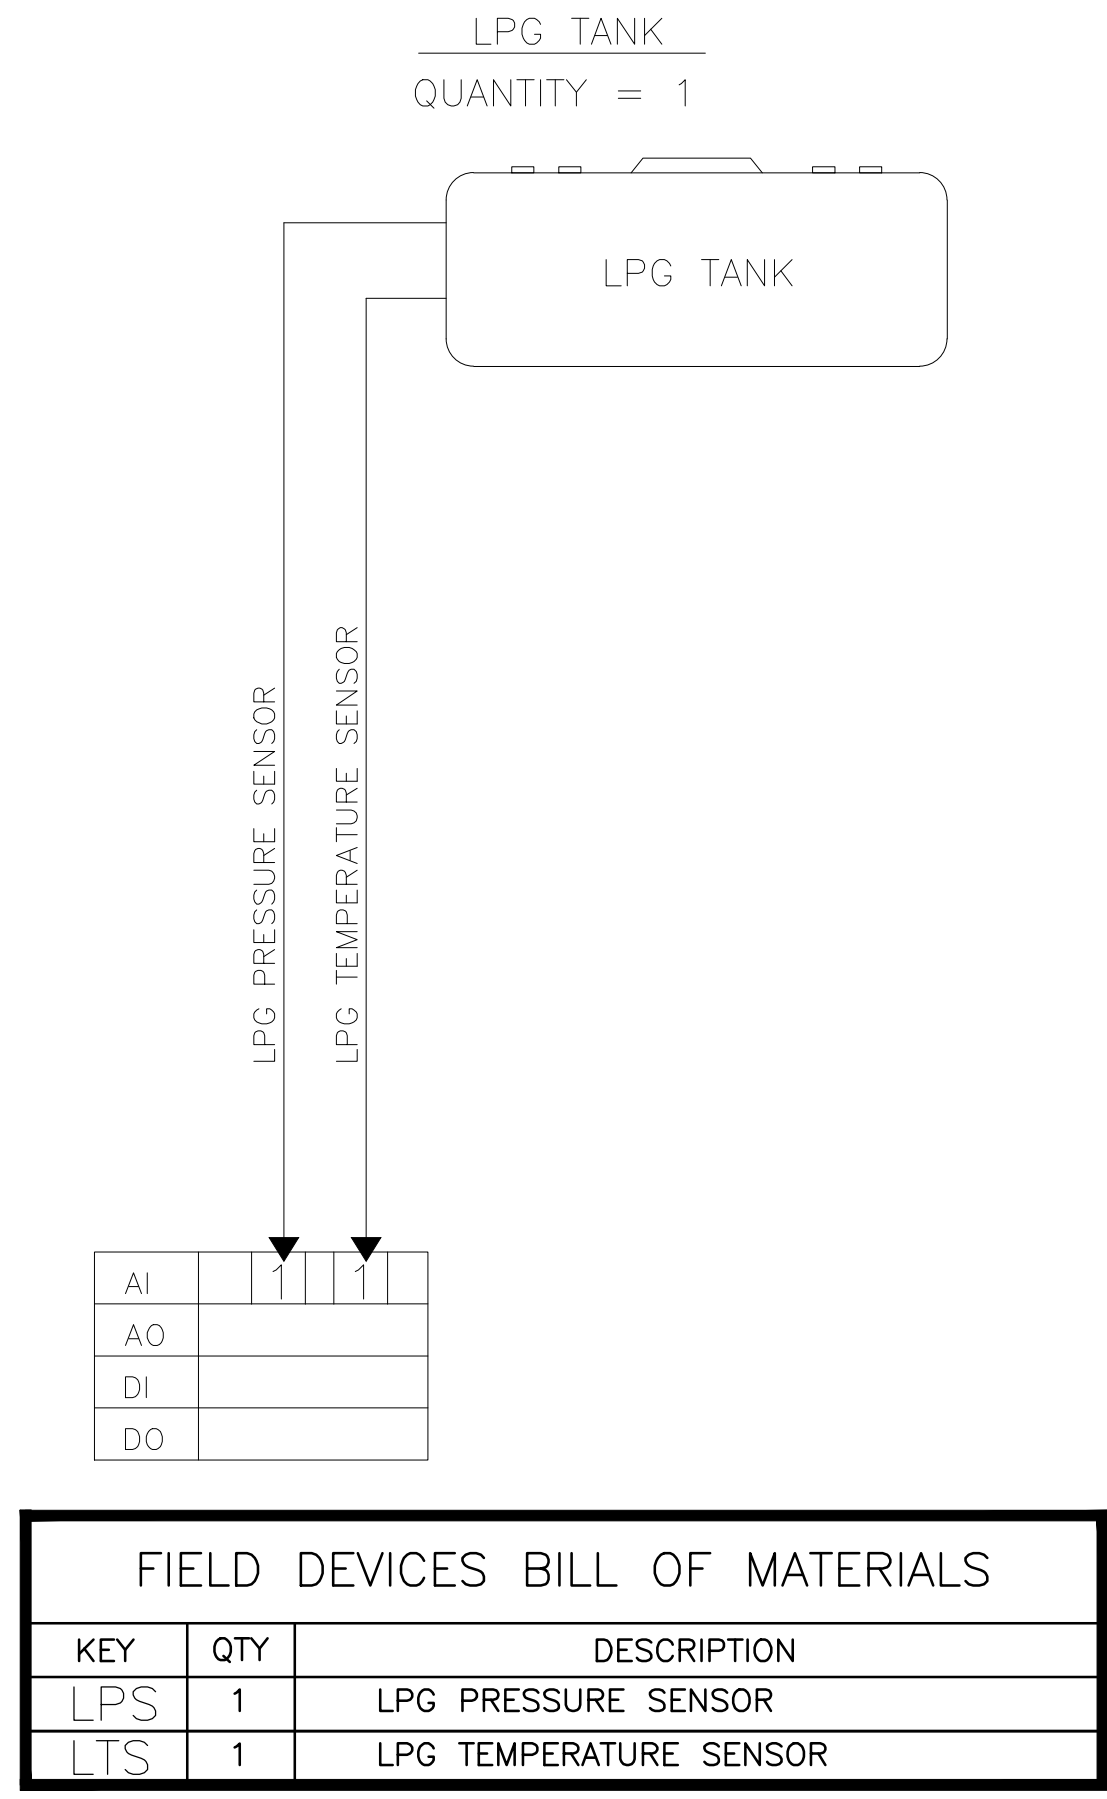

NOTES & LEGEND:

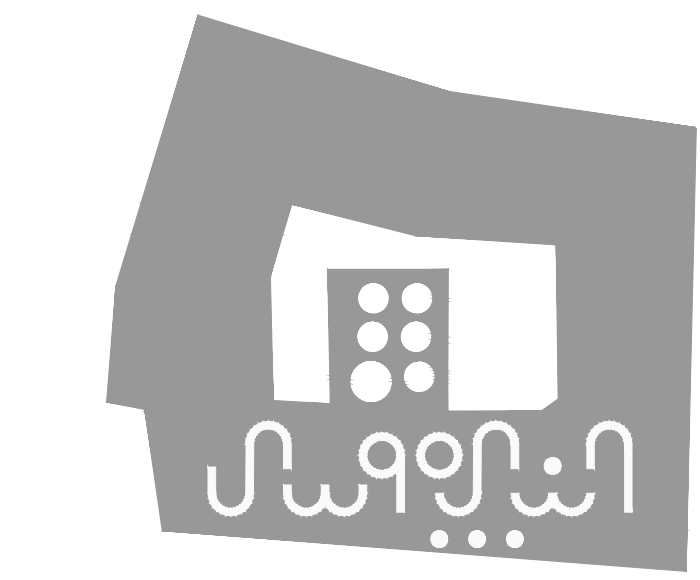

PROJECT:

Securing Professional Services for the Architectural Restoration and Rehabilitation Designs, Archaeological Documentation and Orientation Training, Including Tender Documents Preparation and Site Supervision Works for Conservation and Rehabilitation Works of Maqam Al-Nabi Musa in Jericho Governorate

Support to Development of Cultural Tourism

DESIGN WORKS:

jdc -Jerusalem Design Center

ELECTRICAL WORKS:

-Eng .Midhat AlSharif

MECHANICAL WORKS:

elite -Elite Mechanical Consultants

SHEET NAME:

BMS DIAGRAM- 1

SCALE:

N.T.S

For Review

For Approval

For Tender

For Construction

DATE: July-2016

EDITION:

MECHANICAL


SHEET NO.

M700

jdc JerusalemDesignCenter


Architects, Engineers & Consultants

Phone: 02 234 3096 | Fax: 02 234 3719 | Email: info@jdc.ps

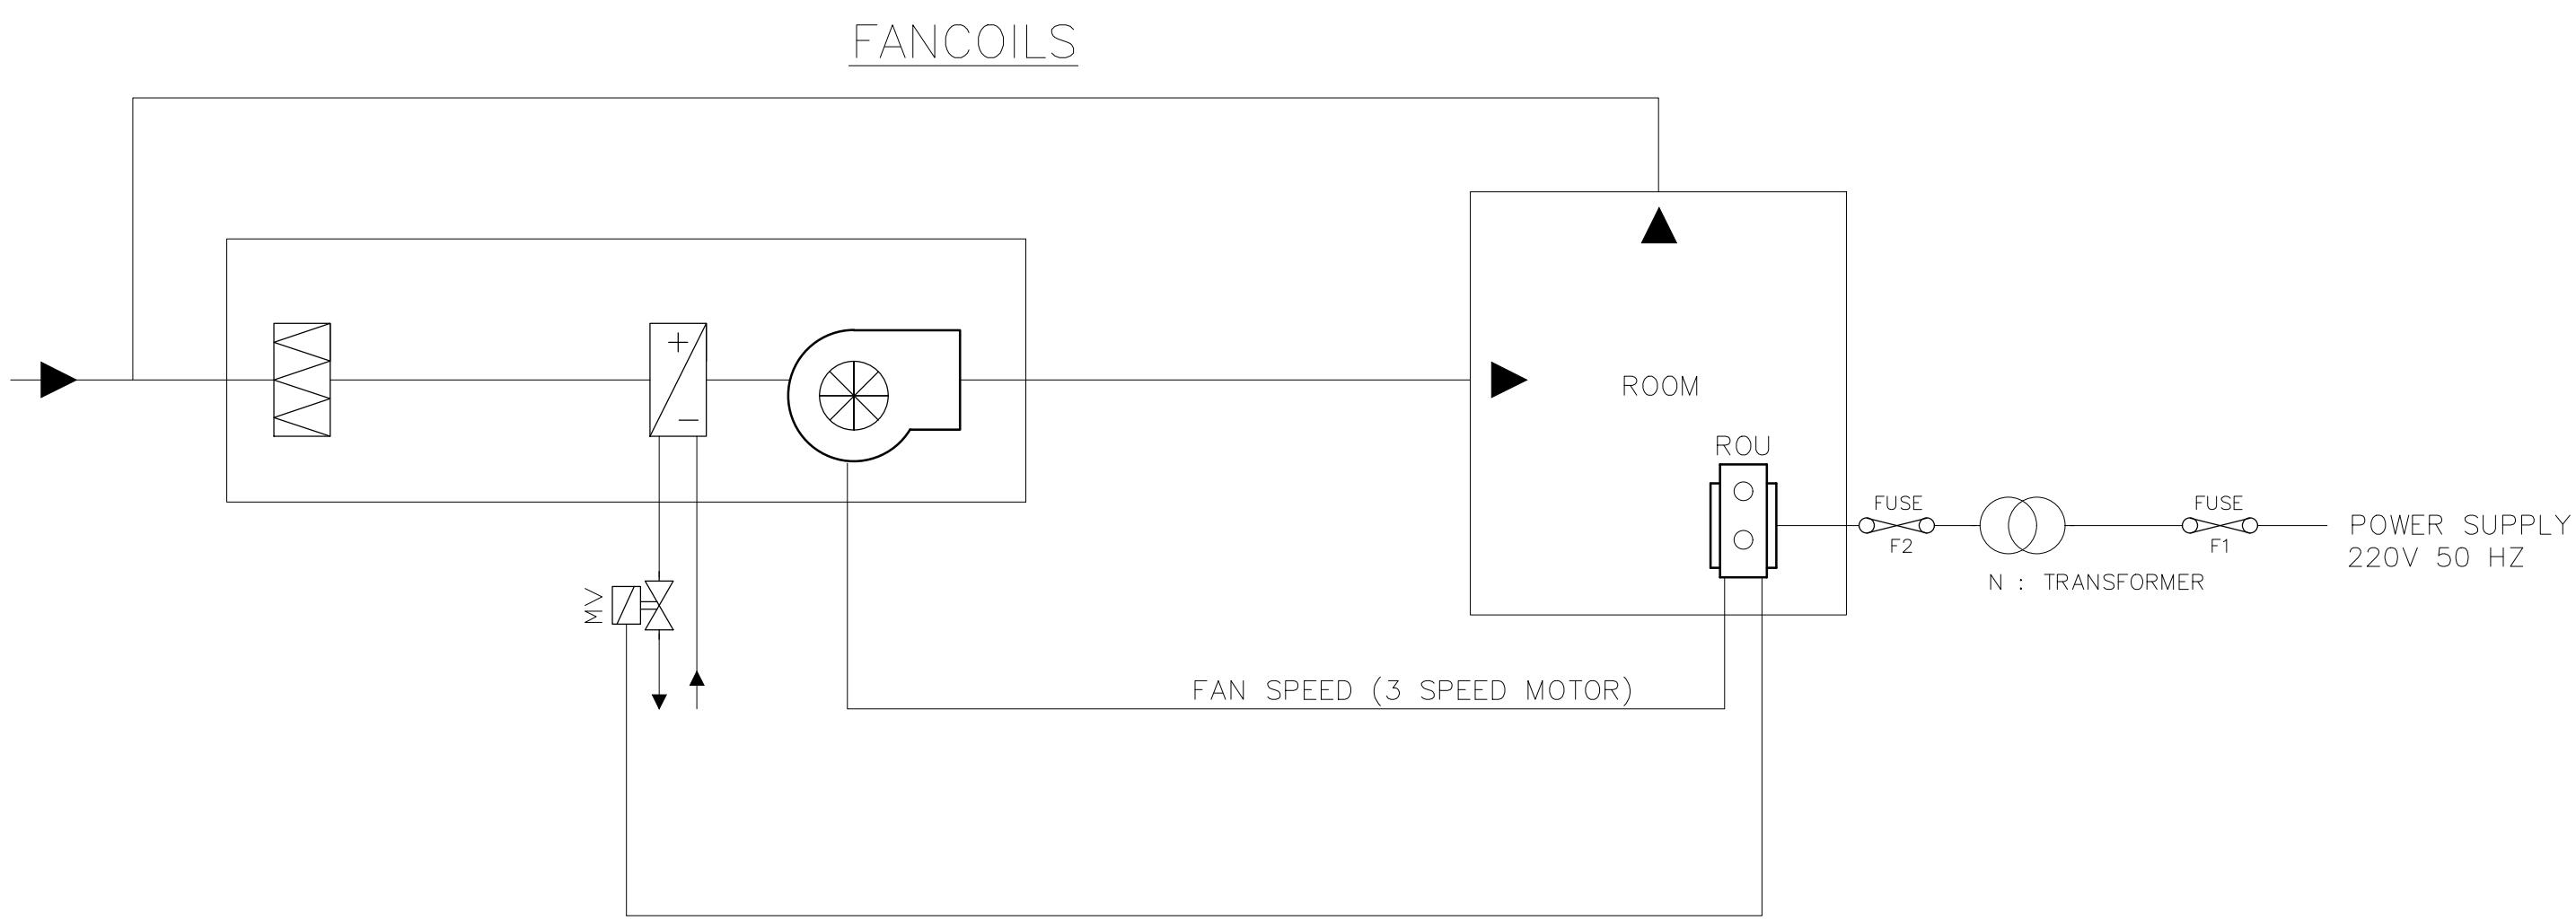


KEY	QTY	DESCRIPTION
MV	74	#30MM MOTORIZED 2 WAY VALVE
SV	20	#25MM MOTORIZED 2 WAY VALVE
ROU	103	ROOM OPERATING UNIT

TYPICAL AXIAL EXTRACT FAN

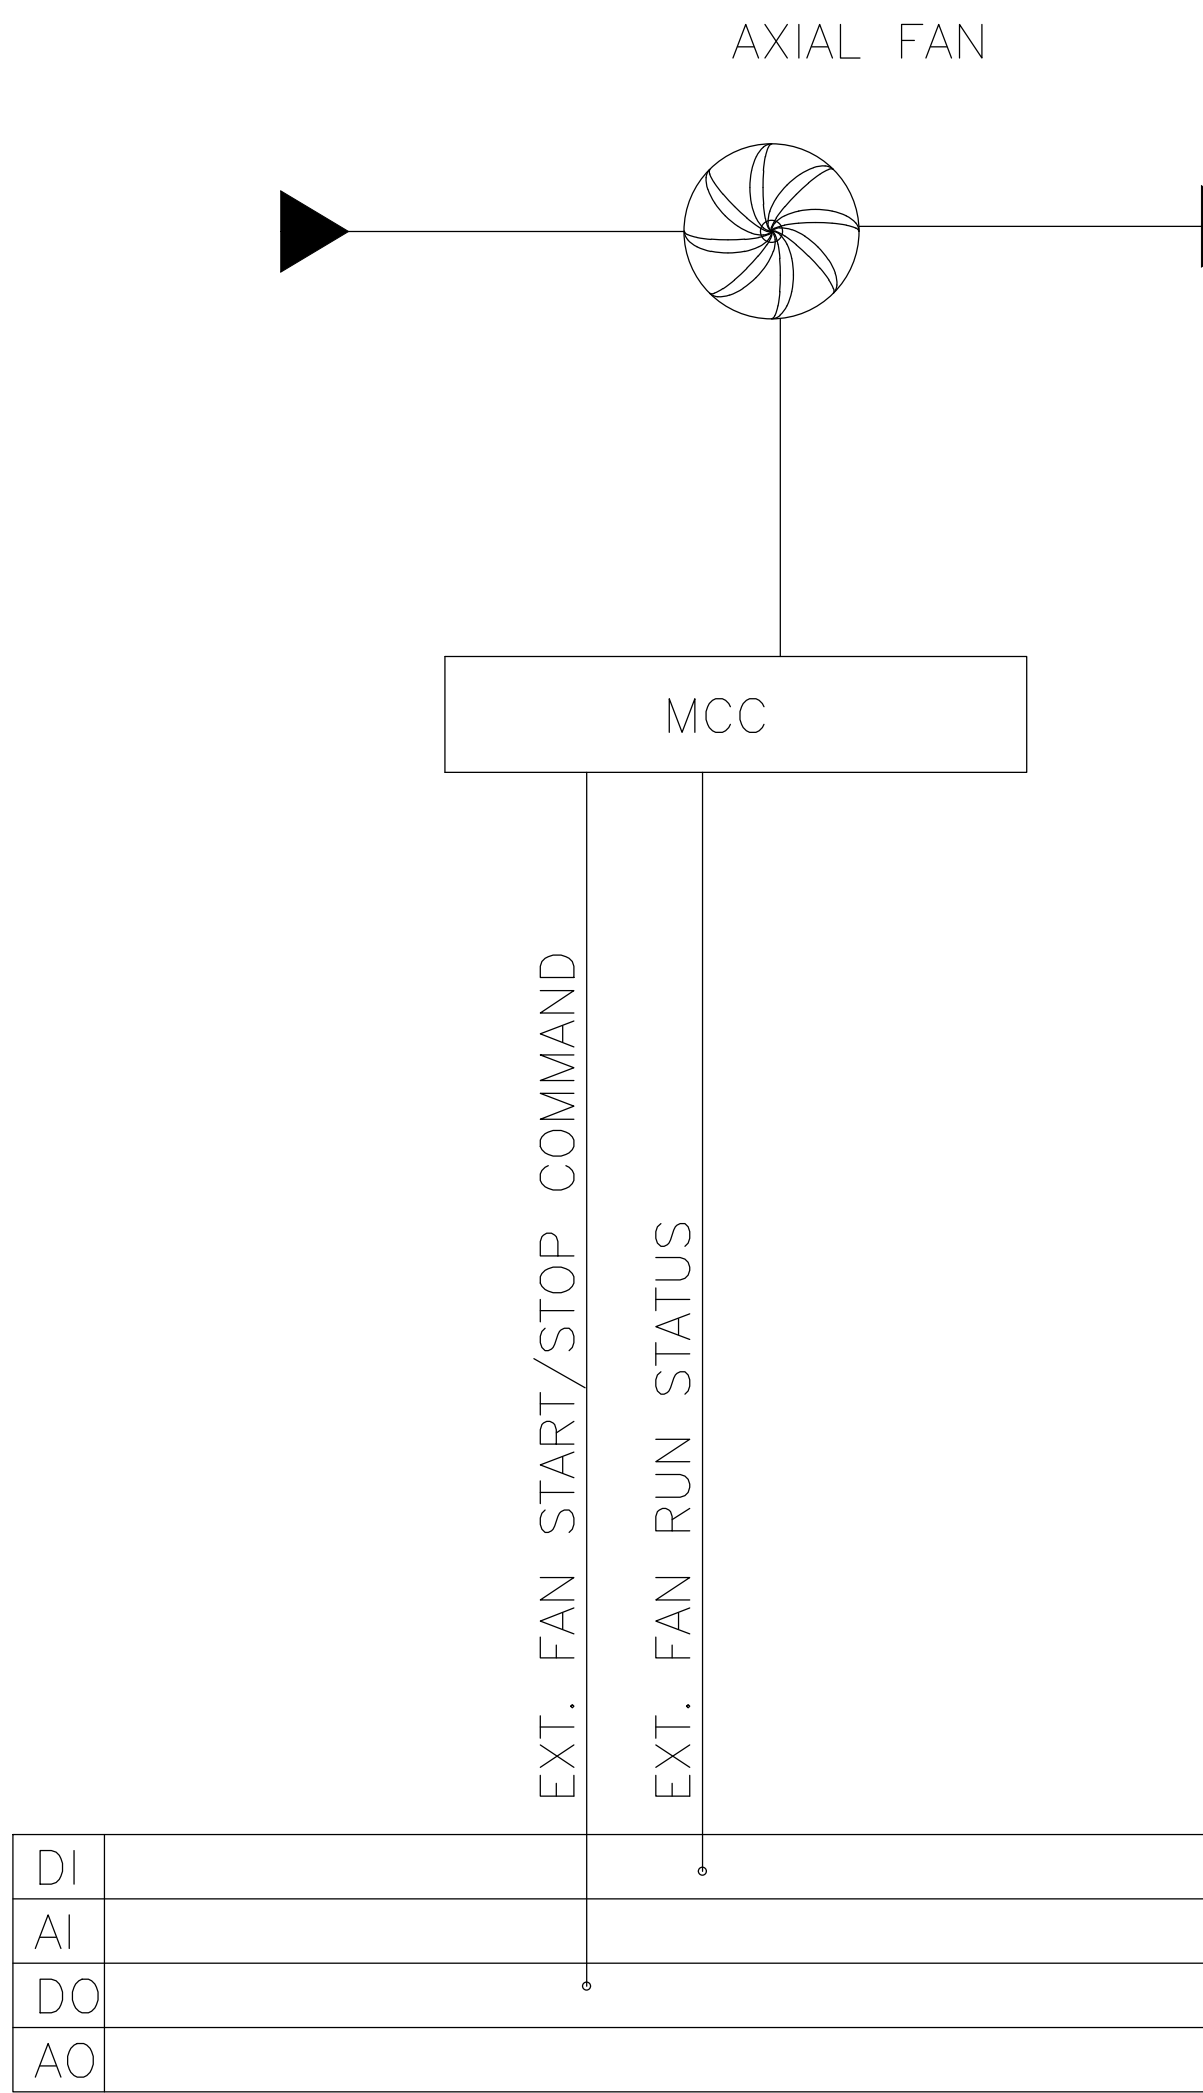


DI	
AI	
DO	
AO	

CONTROL SCHEMATIC DIAGRAM FOR DUCTED FANS

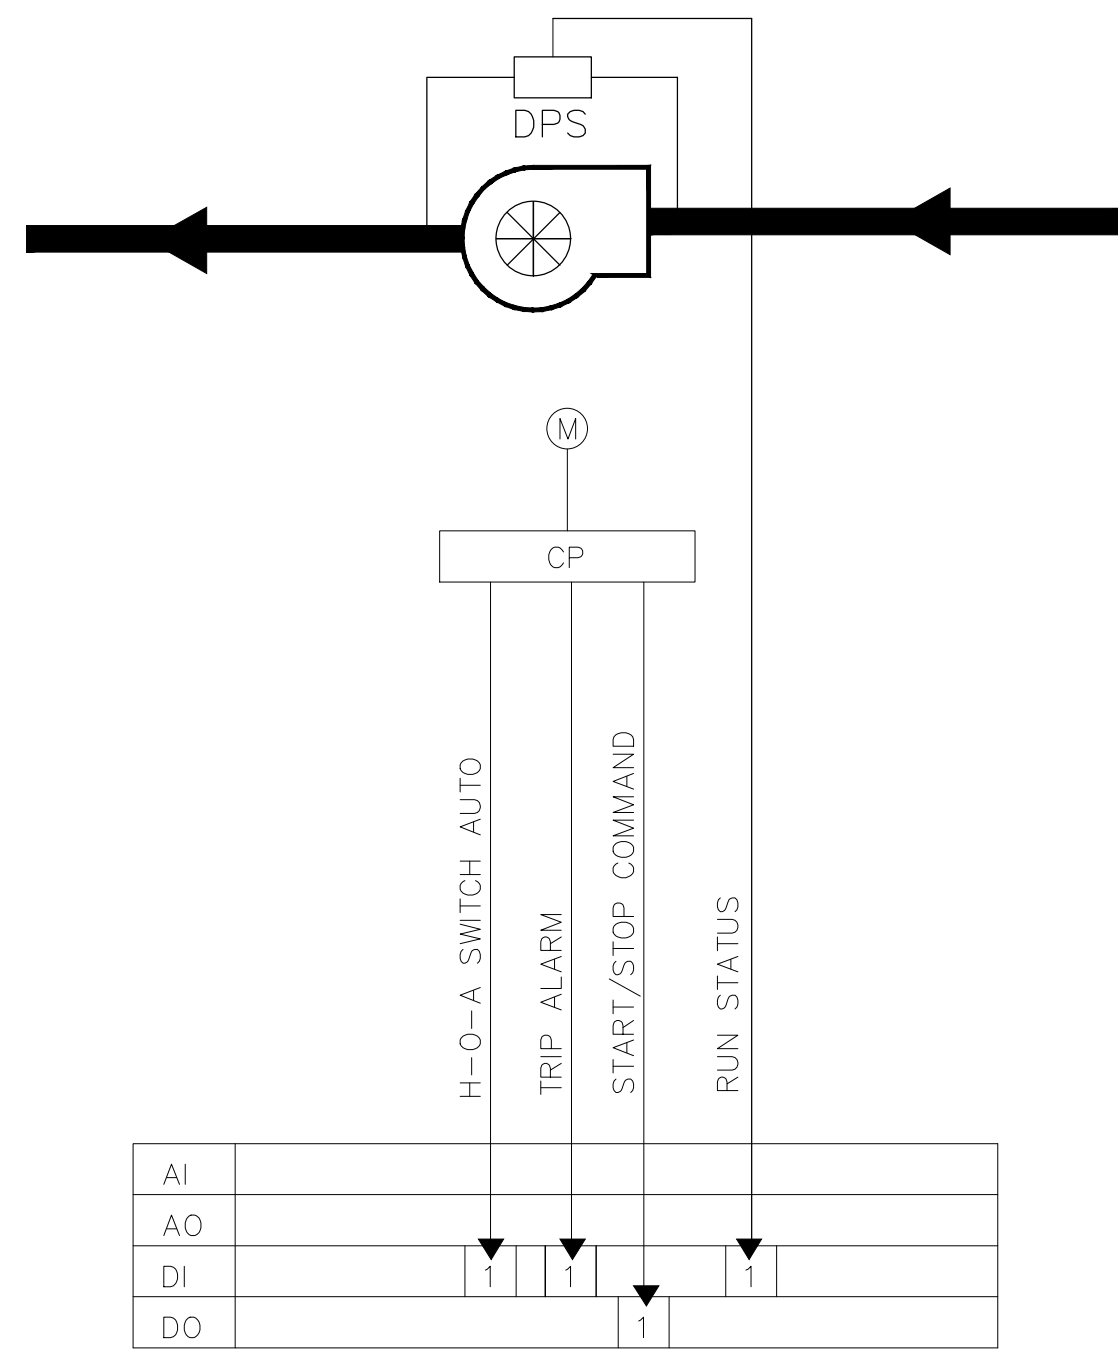


KEY	QTY	DESCRIPTION
DPS	4	DIFFERENTIAL PRESSURE SENSOR FOR AIR

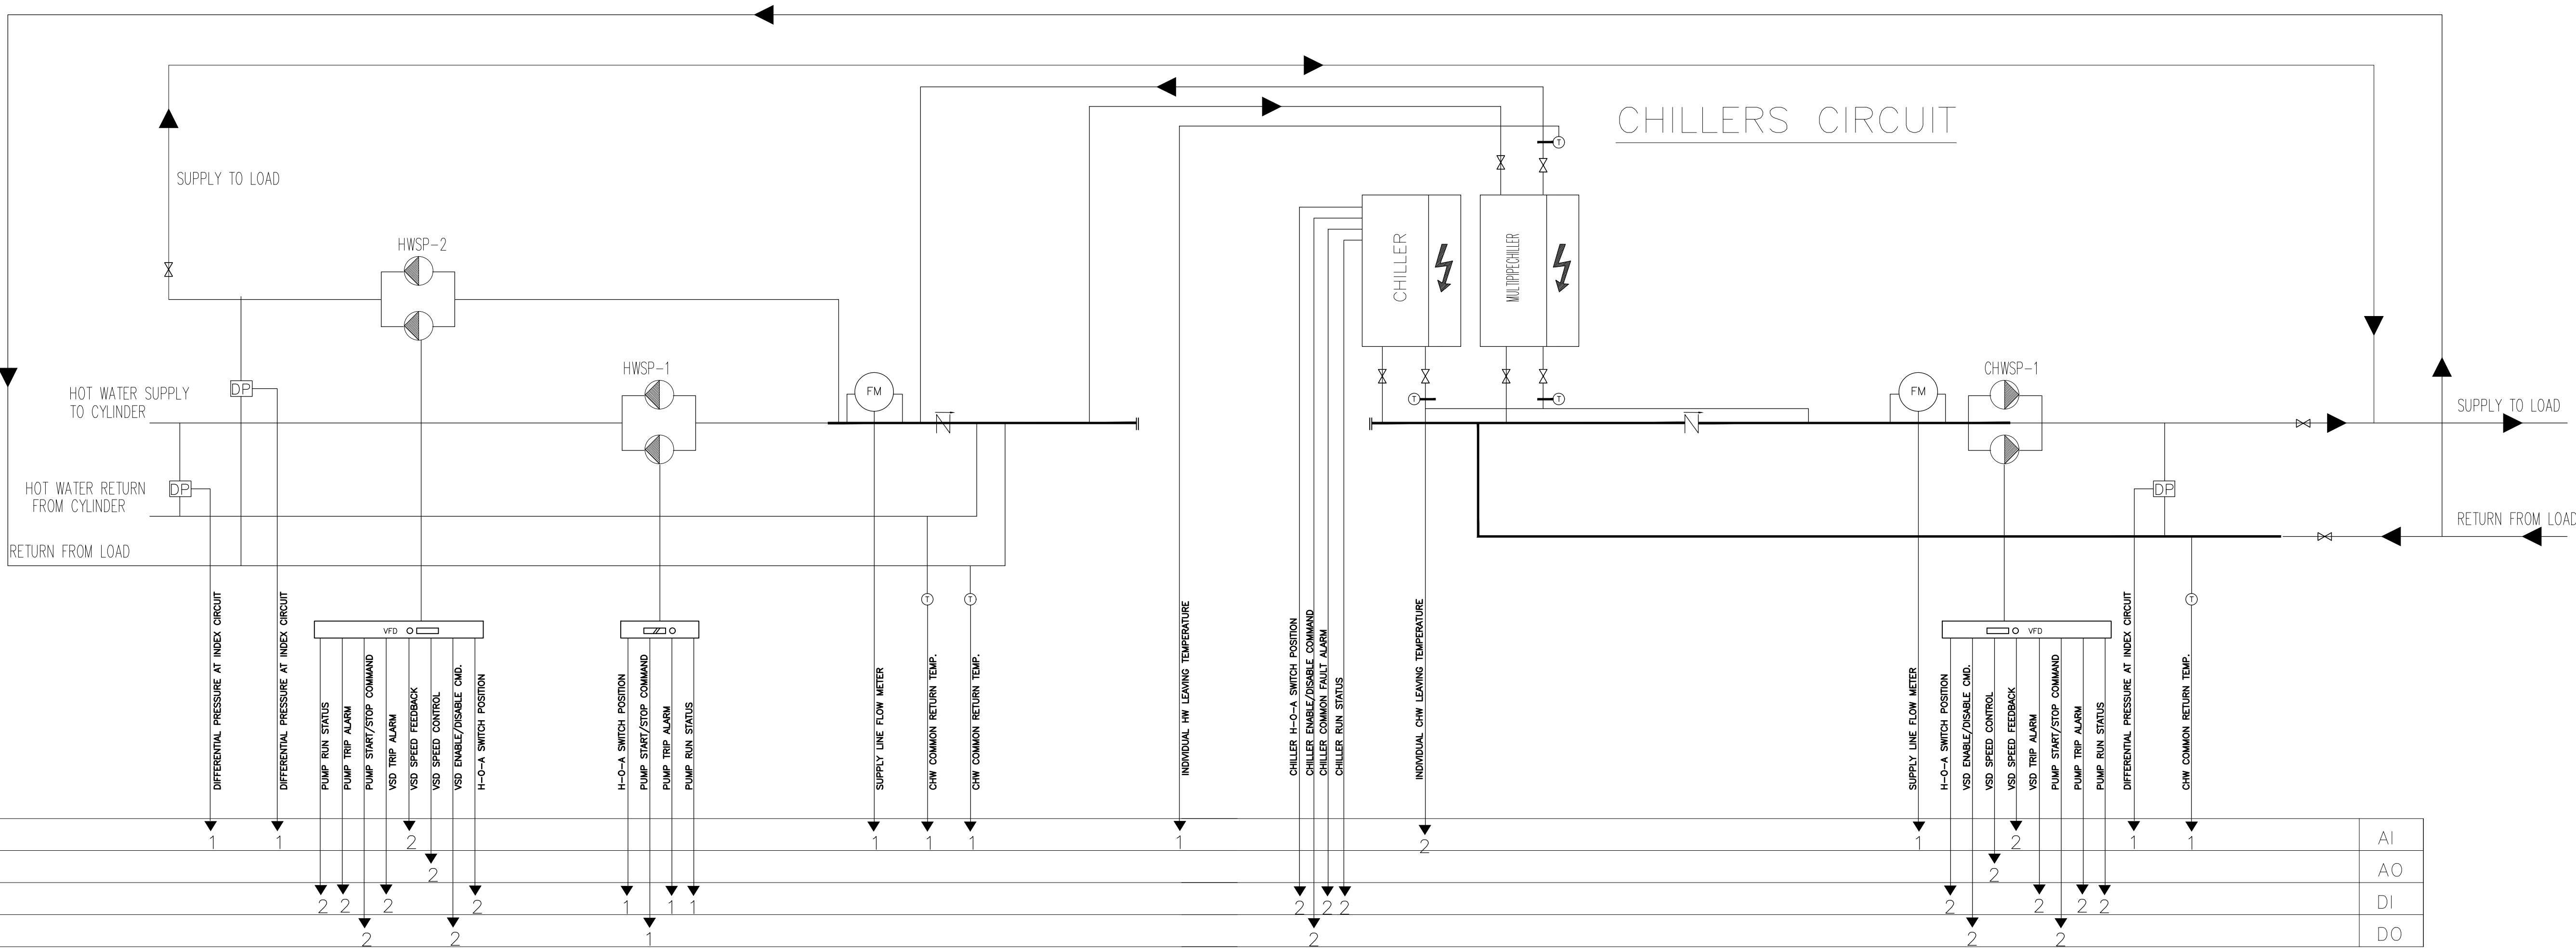

KEY	QTY	DESCRIPTION
T	6	IMMERSION WATER TEMPERATURE SENSOR
DP	3	DIFFERENTIAL PRESSURE SENSOR
FM	2	FLOW METER


CONTROL SCHEMATIC DIAGRAM DRAINAGE PUMPS / SUMP PUMPS(2*SUMP PITS)

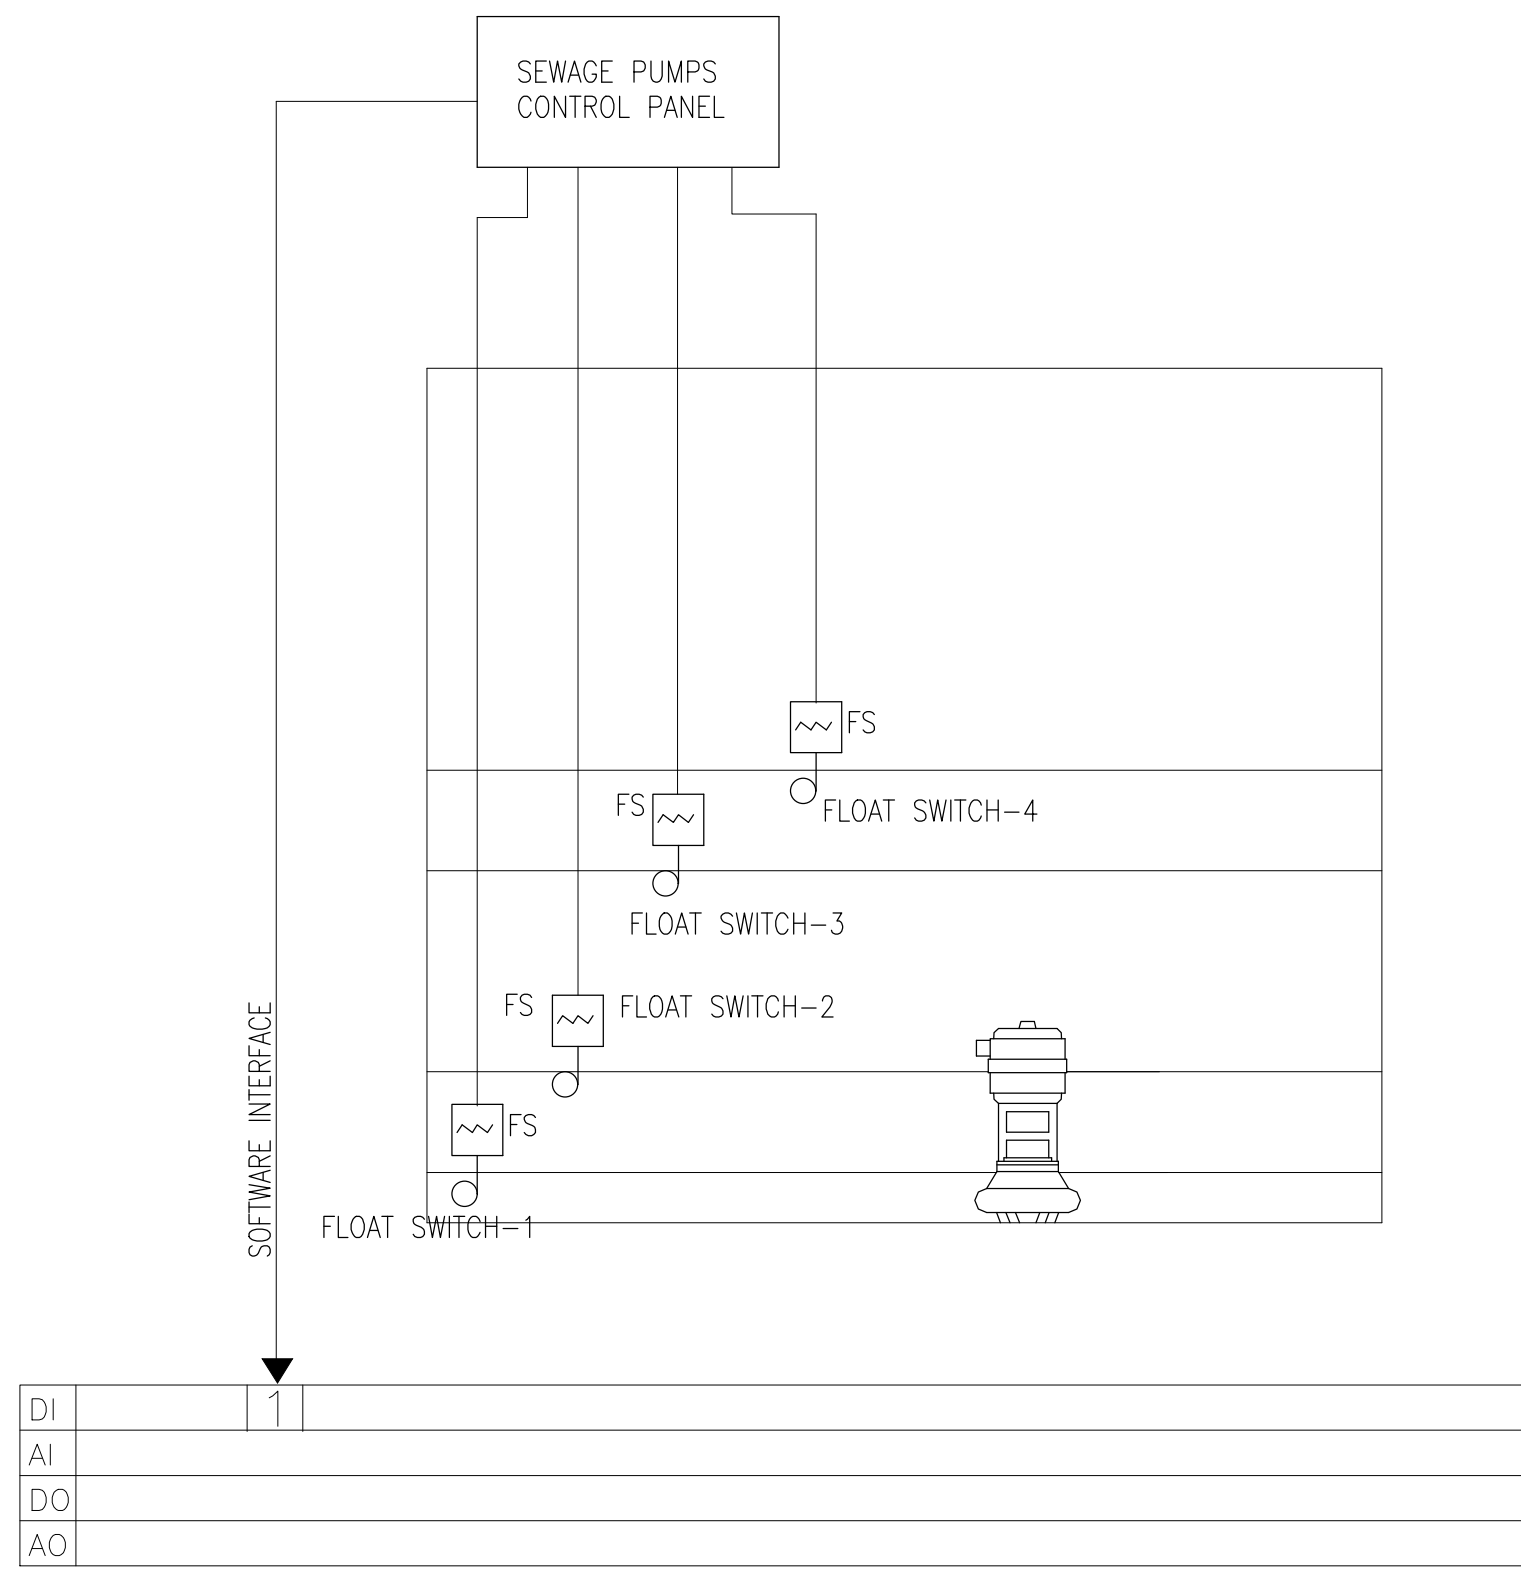

- FOR FLOAT SWITCH-1; A LOW LEVEL ALARM IS INITIATED
- FOR FLOAT SWITCH-2; PUMP STOPS
- FOR FLOAT SWITCH-3; PUMP STARTS
- FOR FLOAT SWITCH-4; A HIGH LEVEL ALARM IS INITIATED

KEY	QTY	DESCRIPTION
FS	8	FLOAT SWITCH

NOTES & LEGEND:

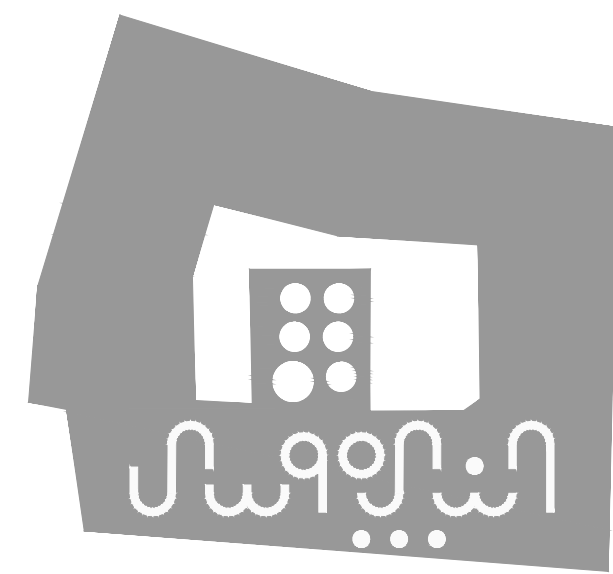

PROJECT:

Securing Professional Services for the Architectural Restoration and Rehabilitation Designs, Archaeological Documentation and Orientation Training, Including Tender Documents Preparation and Site Supervision for Conservation and Rehabilitation Works of Maqam Al-Nabi Musa in Jericho Governorate

Support to Development of Cultural Tourism

DESIGN WORKS:

JD -Jerusalem Design Center

ELECTRICAL WORKS:

Eng. Midhat AlSharif

MECHANICAL WORKS:

elite -Elite Mechanical Consultants

SHEET NAME:

BMS DIAGRAM-2

SCALE:

N.T.S

EDITION:

MECHANICAL


For Review

For Approval

For Tender


For Construction

SHEET NO.

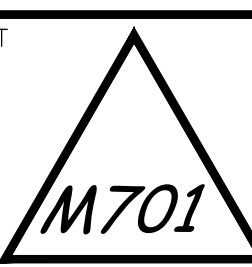


DATE: July-2016



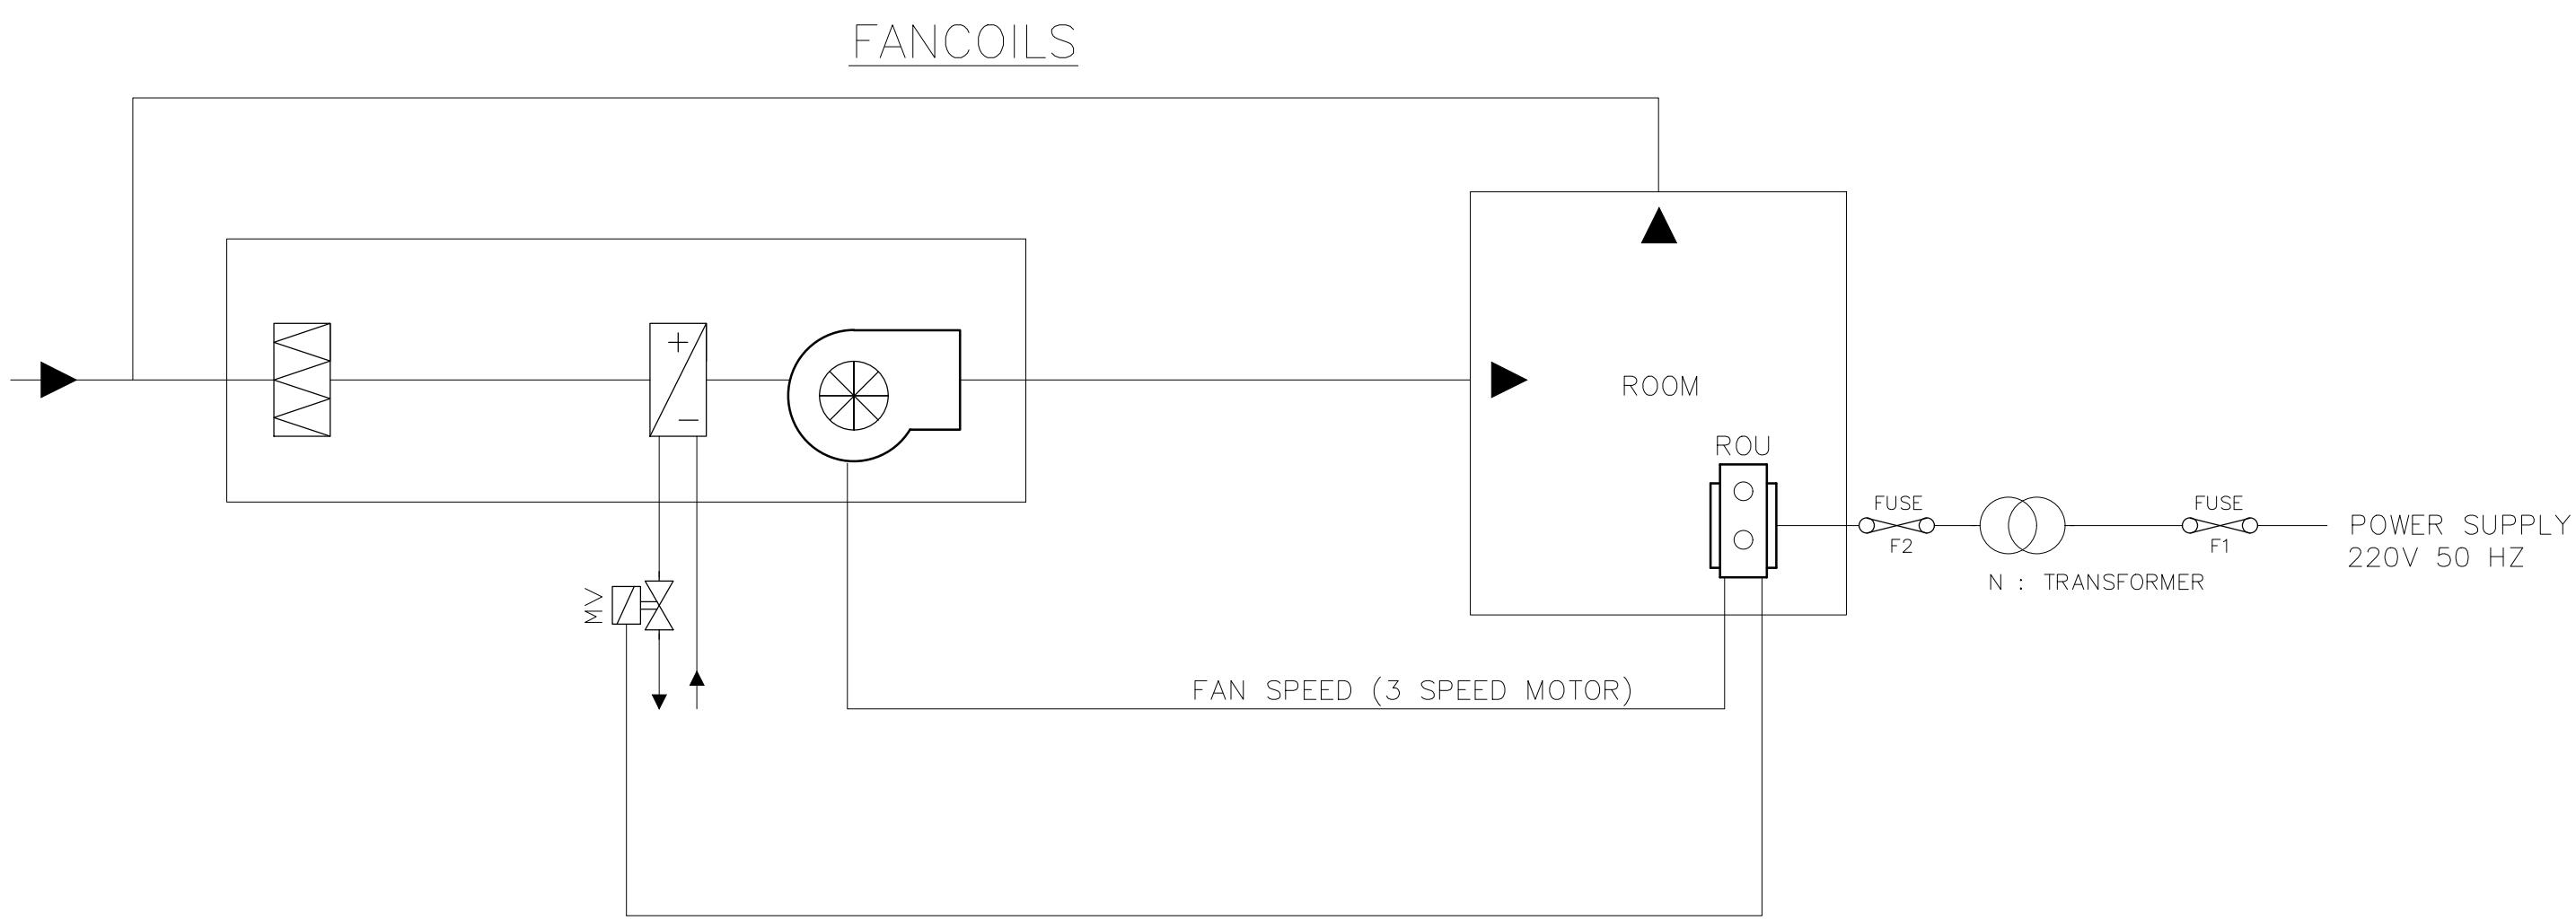


KEY	QTY	DESCRIPTION
MV	74	#30MM MOTORIZED 2 WAY VALVE
SV	20	#20MM MOTORIZED 2 WAY VALVE
ROU	103	ROOM OPERATING UNIT

TYPICAL AXIAL EXTRACT FAN

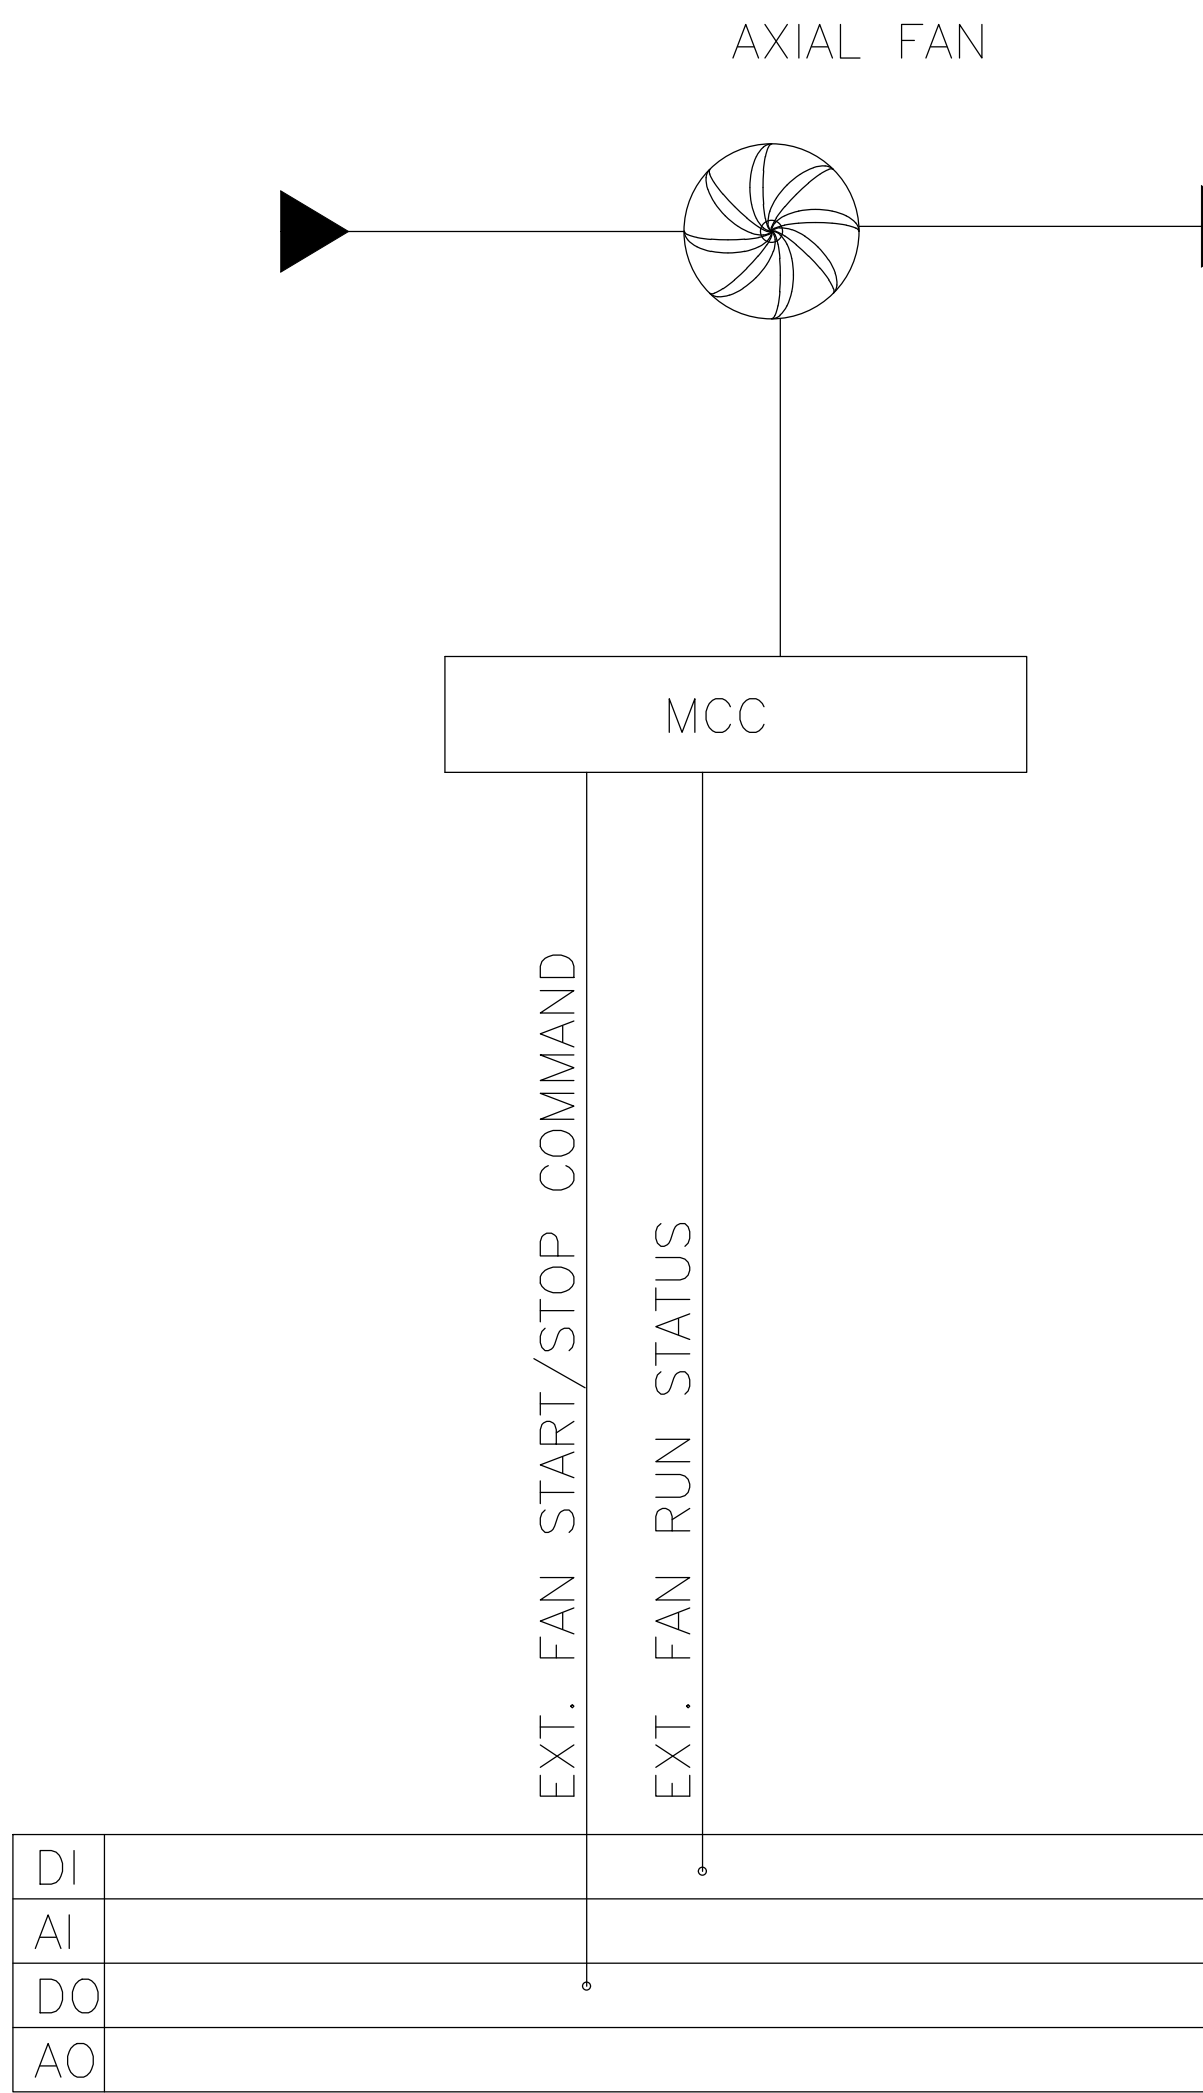


DI	
AI	
DO	
AO	

CONTROL SCHEMATIC DIAGRAM FOR DUCTED FANS

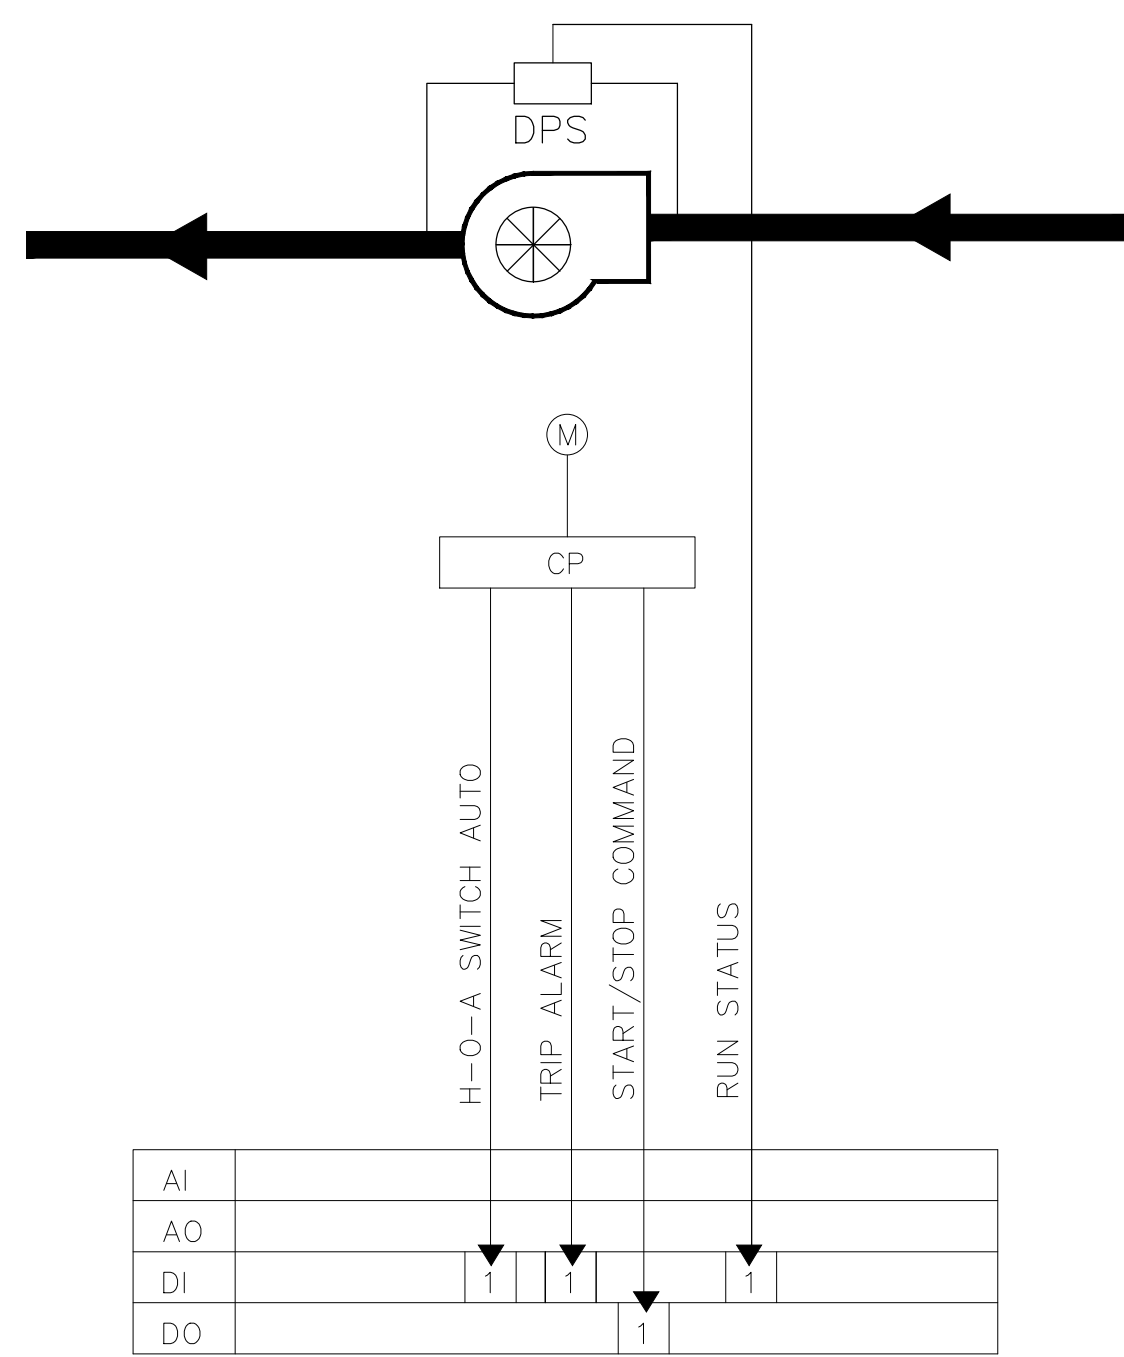


KEY	QTY	DESCRIPTION
DPS	4	DIFFERENTIAL PRESSURE SENSOR FOR AIR

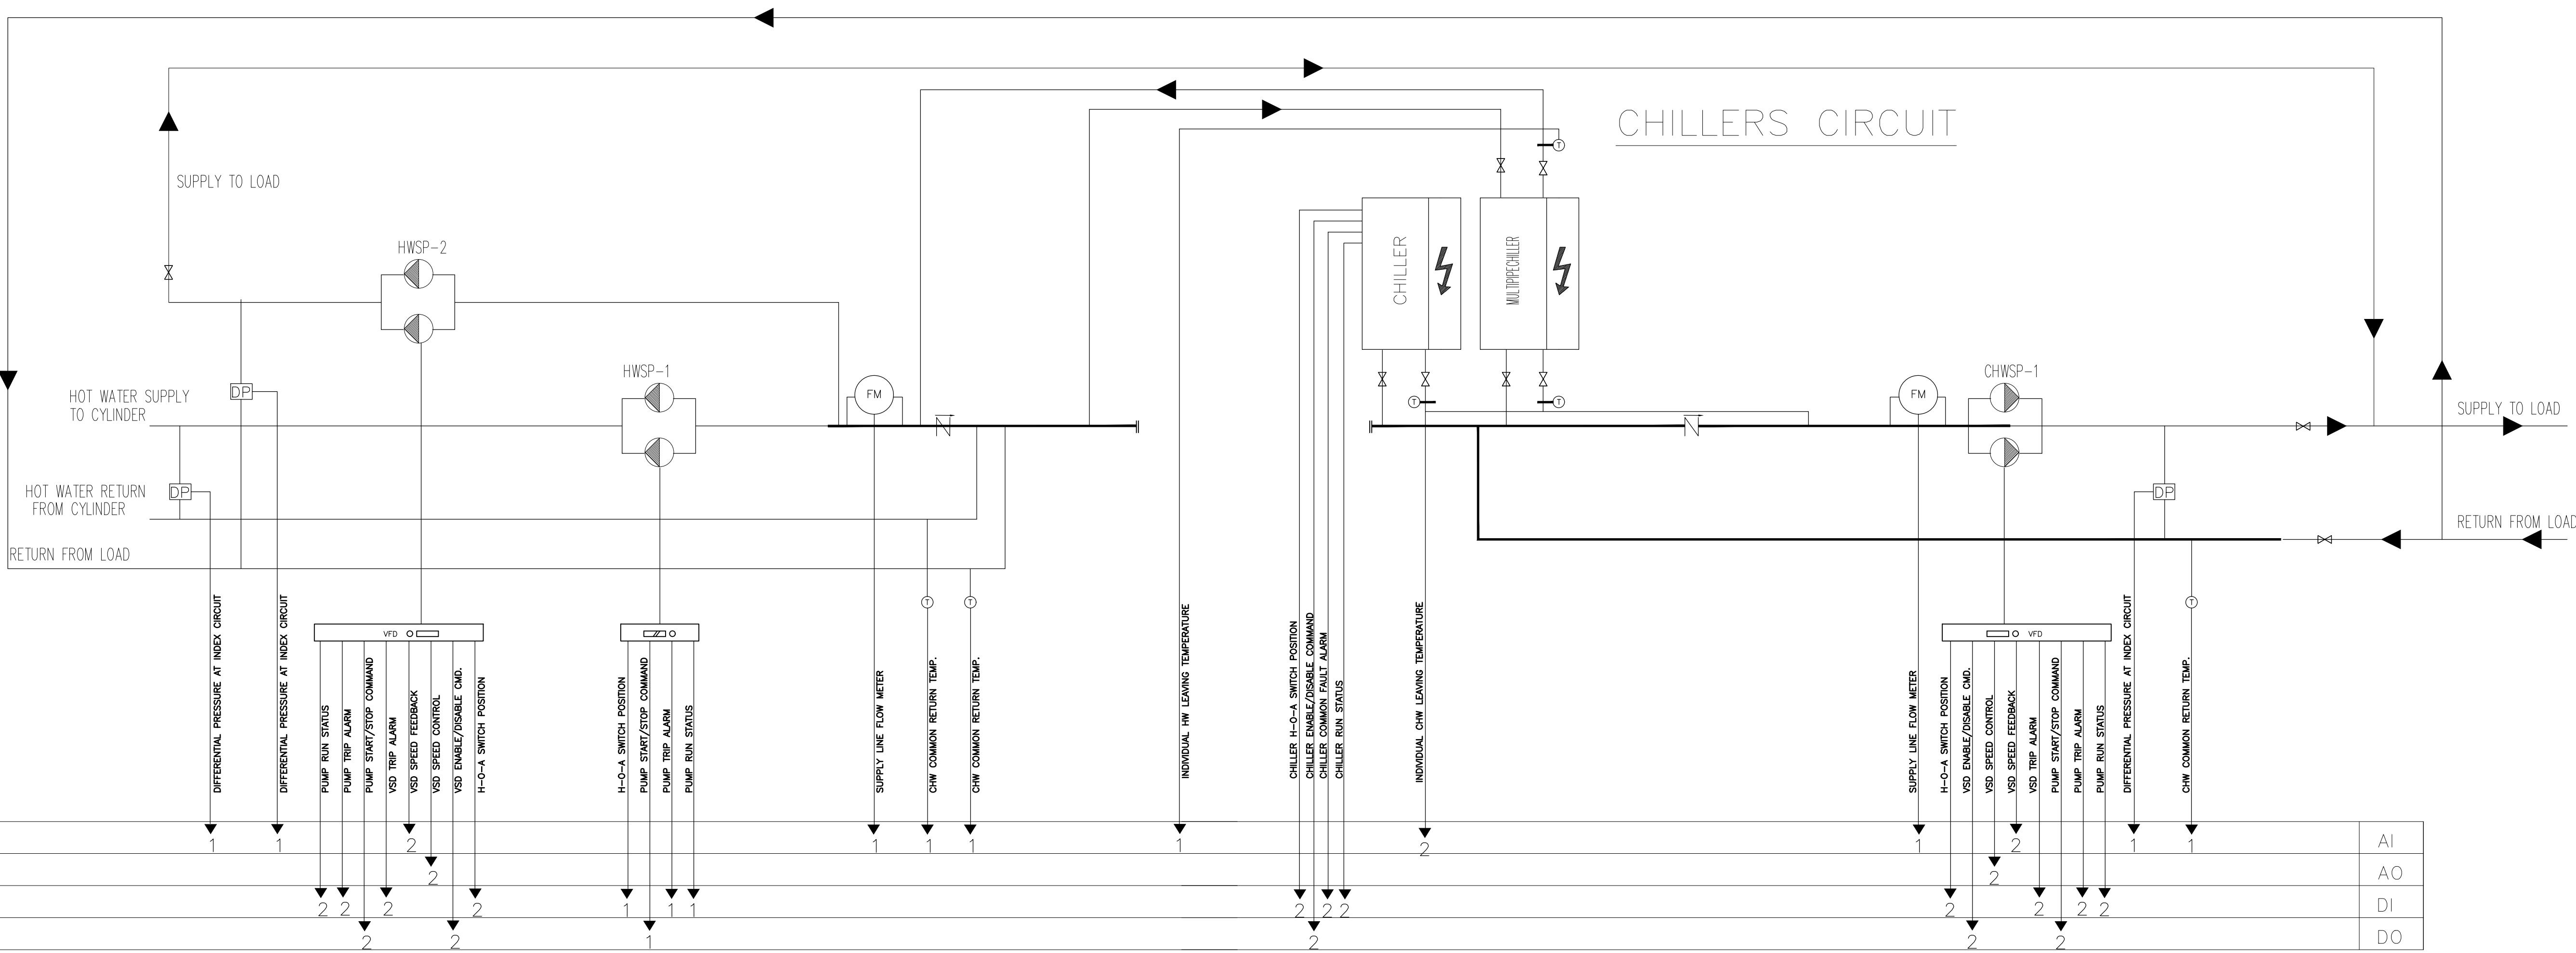

KEY	QTY	DESCRIPTION
T	6	IMMERSION WATER TEMPERATURE SENSOR
DP	3	DIFFERENTIAL PRESSURE SENSOR
FM	2	FLOW METER


CONTROL SCHEMATIC DIAGRAM DRAINAGE PUMPS / SUMP PUMPS(2*SUMP PITS)

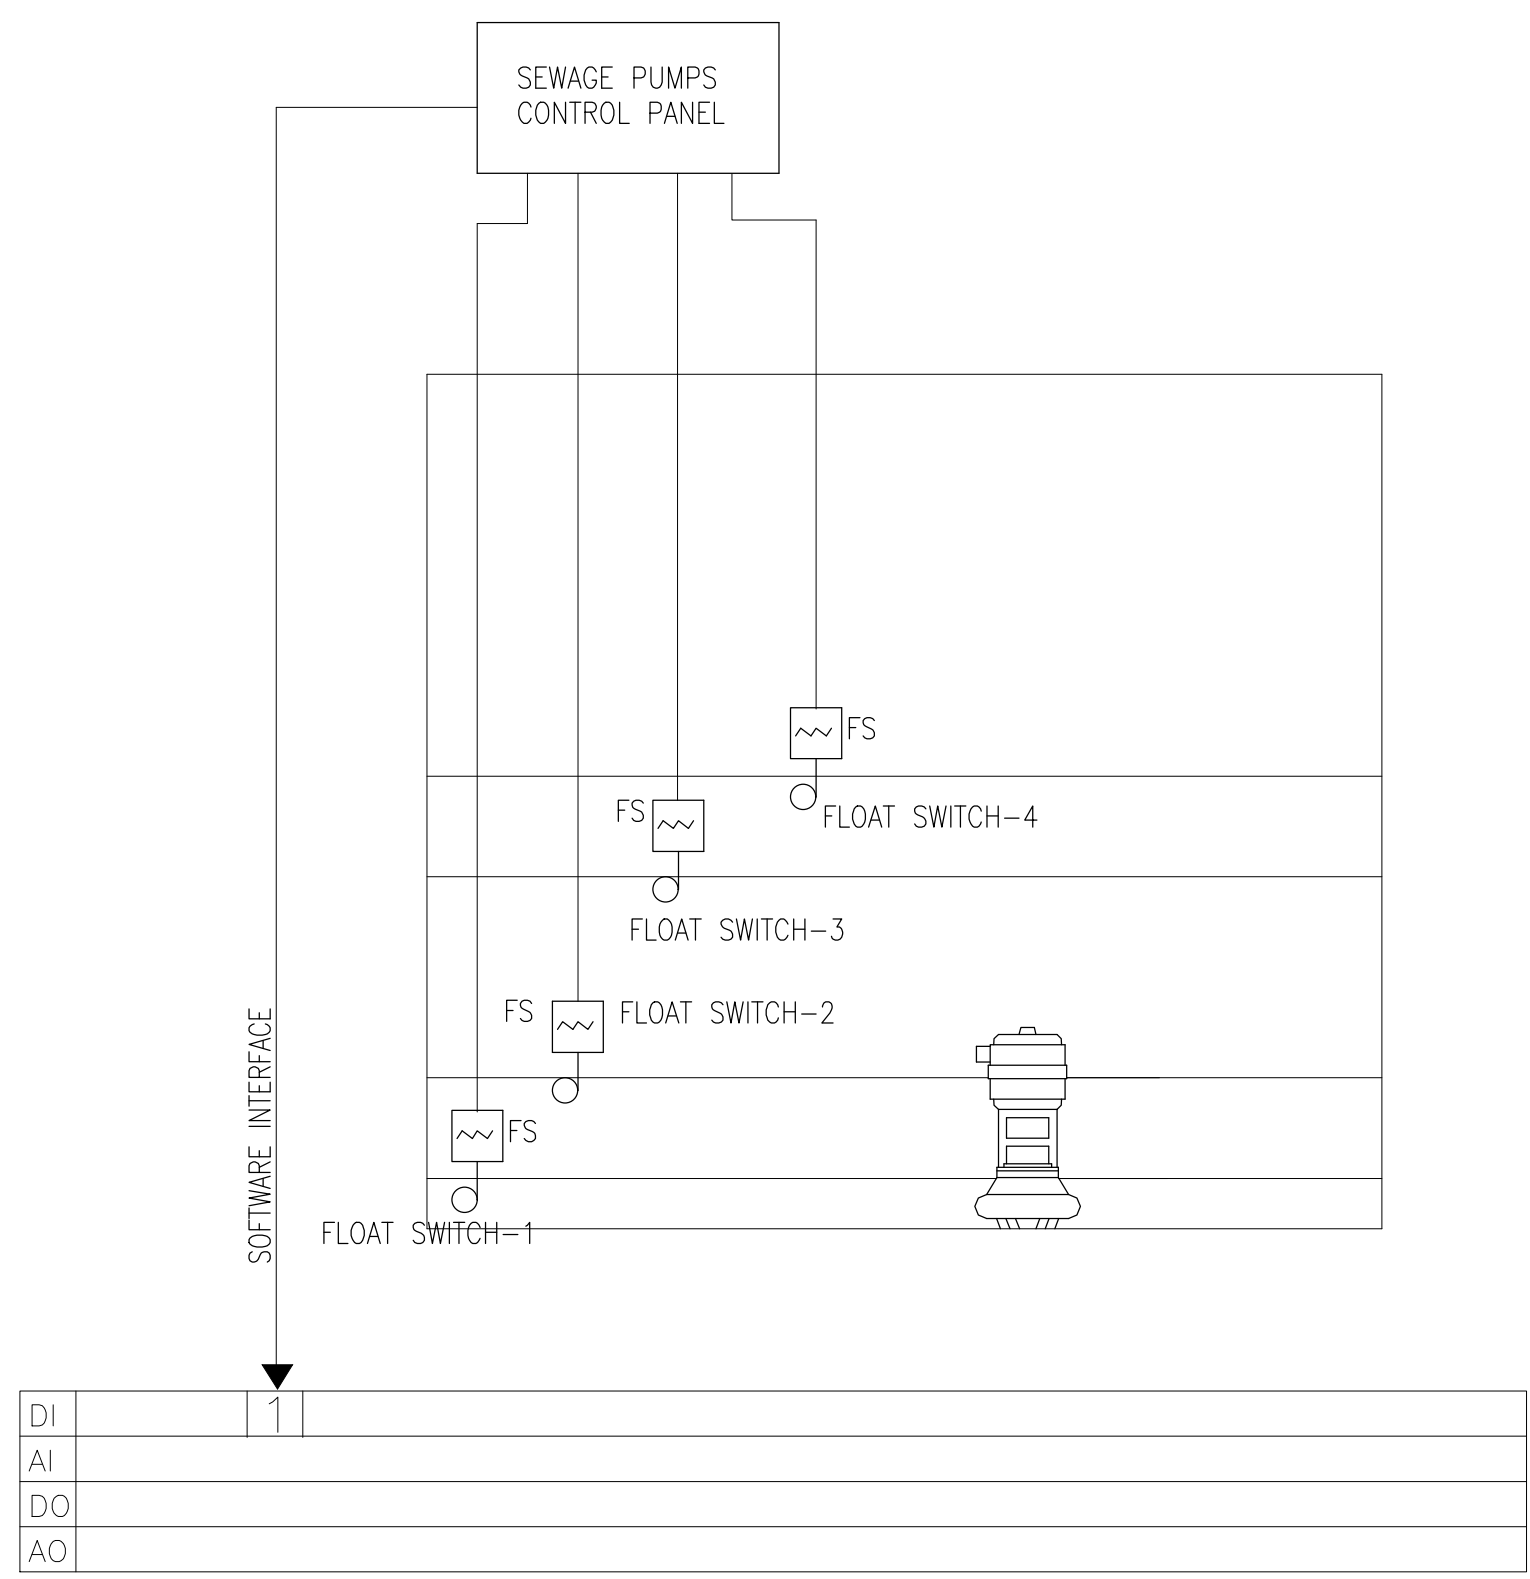

- FOR FLOAT SWITCH-1; A LOW LEVEL ALARM IS INITIATED
- FOR FLOAT SWITCH-2; PUMP STOPS
- FOR FLOAT SWITCH-3; PUMP STARTS
- FOR FLOAT SWITCH-4; A HIGH LEVEL ALARM IS INITIATED

KEY	QTY	DESCRIPTION
FS	8	FLOAT SWITCH

NOTES & LEGEND:

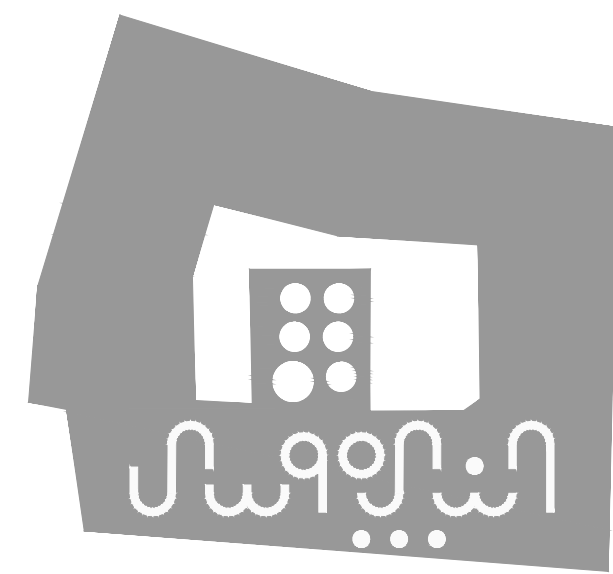

PROJECT:

Securing Professional Services for the Architectural Restoration and Rehabilitation Designs, Archaeological Documentation and Orientation Training, Including Tender Documents Preparation and Site Supervision for Conservation and Rehabilitation Works of Maqam Al-Nabi Musa in Jericho Governorate

Support to Development of Cultural Tourism

DESIGN WORKS:

Jerusalem Design Center

ELECTRICAL WORKS:

-Eng. Midhat AlSharif

MECHANICAL WORKS:

-Elite Mechanical Consultants

SHEET NAME:

SCHEMATIC FOR BMS CONTROL

SCALE:

N.T.S

EDITION:

MECHANICAL


For Review

For Approval

For Tender

For Construction

SHEET NO.

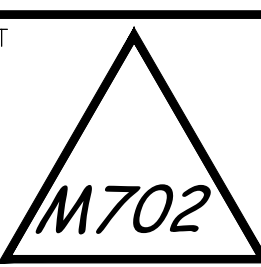

DATE: July-2016

