



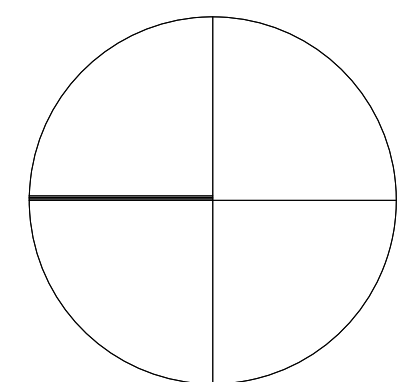

NOTES & LEGEND:

SYMBOL	DESCRIPTION
FIRE ALARM SYSTEM	
Ⓢ	PHOTO SMOKE SENSOR
Ⓢ	HEAT DETECTOR
MS	BREAK GLASS
Ⓢ	INTERNAL SIREN
CM	CONTROL MODULE
Ⓢ	EXTERNAL SIREN WITH FALSHER
Ⓢ	Beam Detector-Receiver
Ⓢ	Beam Detector-Transmitter
+	DETECTOR INDICATION LAMP
Ⓢ	PHOTOELECTRIC SMOKE DET. ABOVE FAULT/SECURING
FACP	FIRE ALARM CONTROL PANEL
RP	REPEATER PANEL WITH CONTROL
Ⓢ	FIRE INDICATOR LAMP SIGN

SYMBOL	DESCRIPTION	Hz (cm.) a/f
SOUND SYSTEM		
Ⓢ	6WATT RECESSED LOUD SPEAKER	CEILING
Ⓢ	6WATT SURFACE MOUNT LOUD SPEAKER	220
Ⓢ	25W WALL MOUNTED ADJUSTABLE HORN	220
Ⓢ	END OF THE LINE	CEILING
Ⓢ	VOLUME CONTROL	150
Ⓢ	16 BUTTON CALL STATION	Table
Ⓢ	PUBLIC ADDRESS AND VOICE ALARM RACK	180
Ⓢ	PENDANT SPEAKER	
Ⓢ	CEILING SPEAKER	
Ⓢ	WALL MOUNT SPEAKER	
Ⓢ	COLUMN SPEAKER 0.5M	
Ⓢ	COLUMN SPEAKER 1.0M	
Ⓢ	HORN SPEAKER	
Ⓢ	Horn speaker 2 way	
Ⓢ	Microphone XLR box	
Ⓢ	Zone No.	
Ⓢ	42 U rack cabinet	

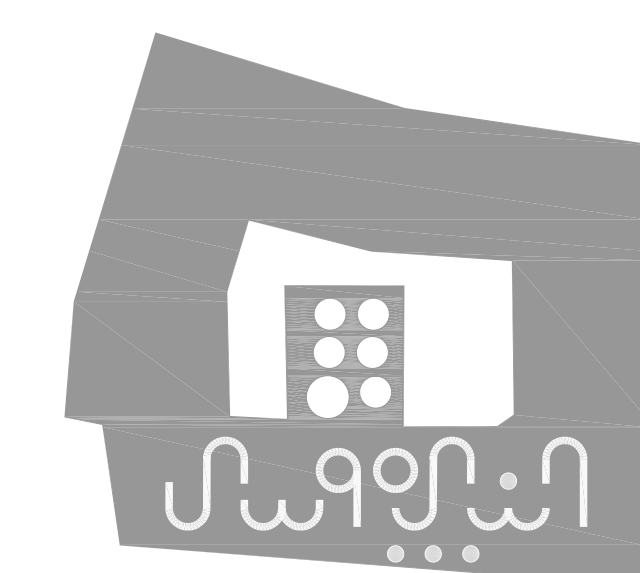

PROJECT:

Securing Professional Services for the Architectural Restoration and Rehabilitation Designs, Archaeological Documentation and Orientation Training, Including Tender Documents Preparation and Site Supervision for Conservation and Rehabilitation Works of Maqam Al-Nabi Musa in Jericho Governorate

Support to Development of Cultural Tourism

DESIGN WORKS:

-Jerusalem Design Center

ELECTRICAL WORKS:

-Eng .Midhat AlSharif

MECHANICAL WORKS:

-Elite Mechanical Consultants


SHEET NAME:
Ground Floor
Fire Alarm &
Public Address Systems


SCALE: 1:100
if plotted on A0

EDITION:
SHEET NO.
E-12

DATE: July-2016


jdc Jerusalem Design Center
Architects, Engineers & Consultants
Phone: 02 234 3696 | Fax: 02 234 3718 | Email: info@jdc.gov.ps

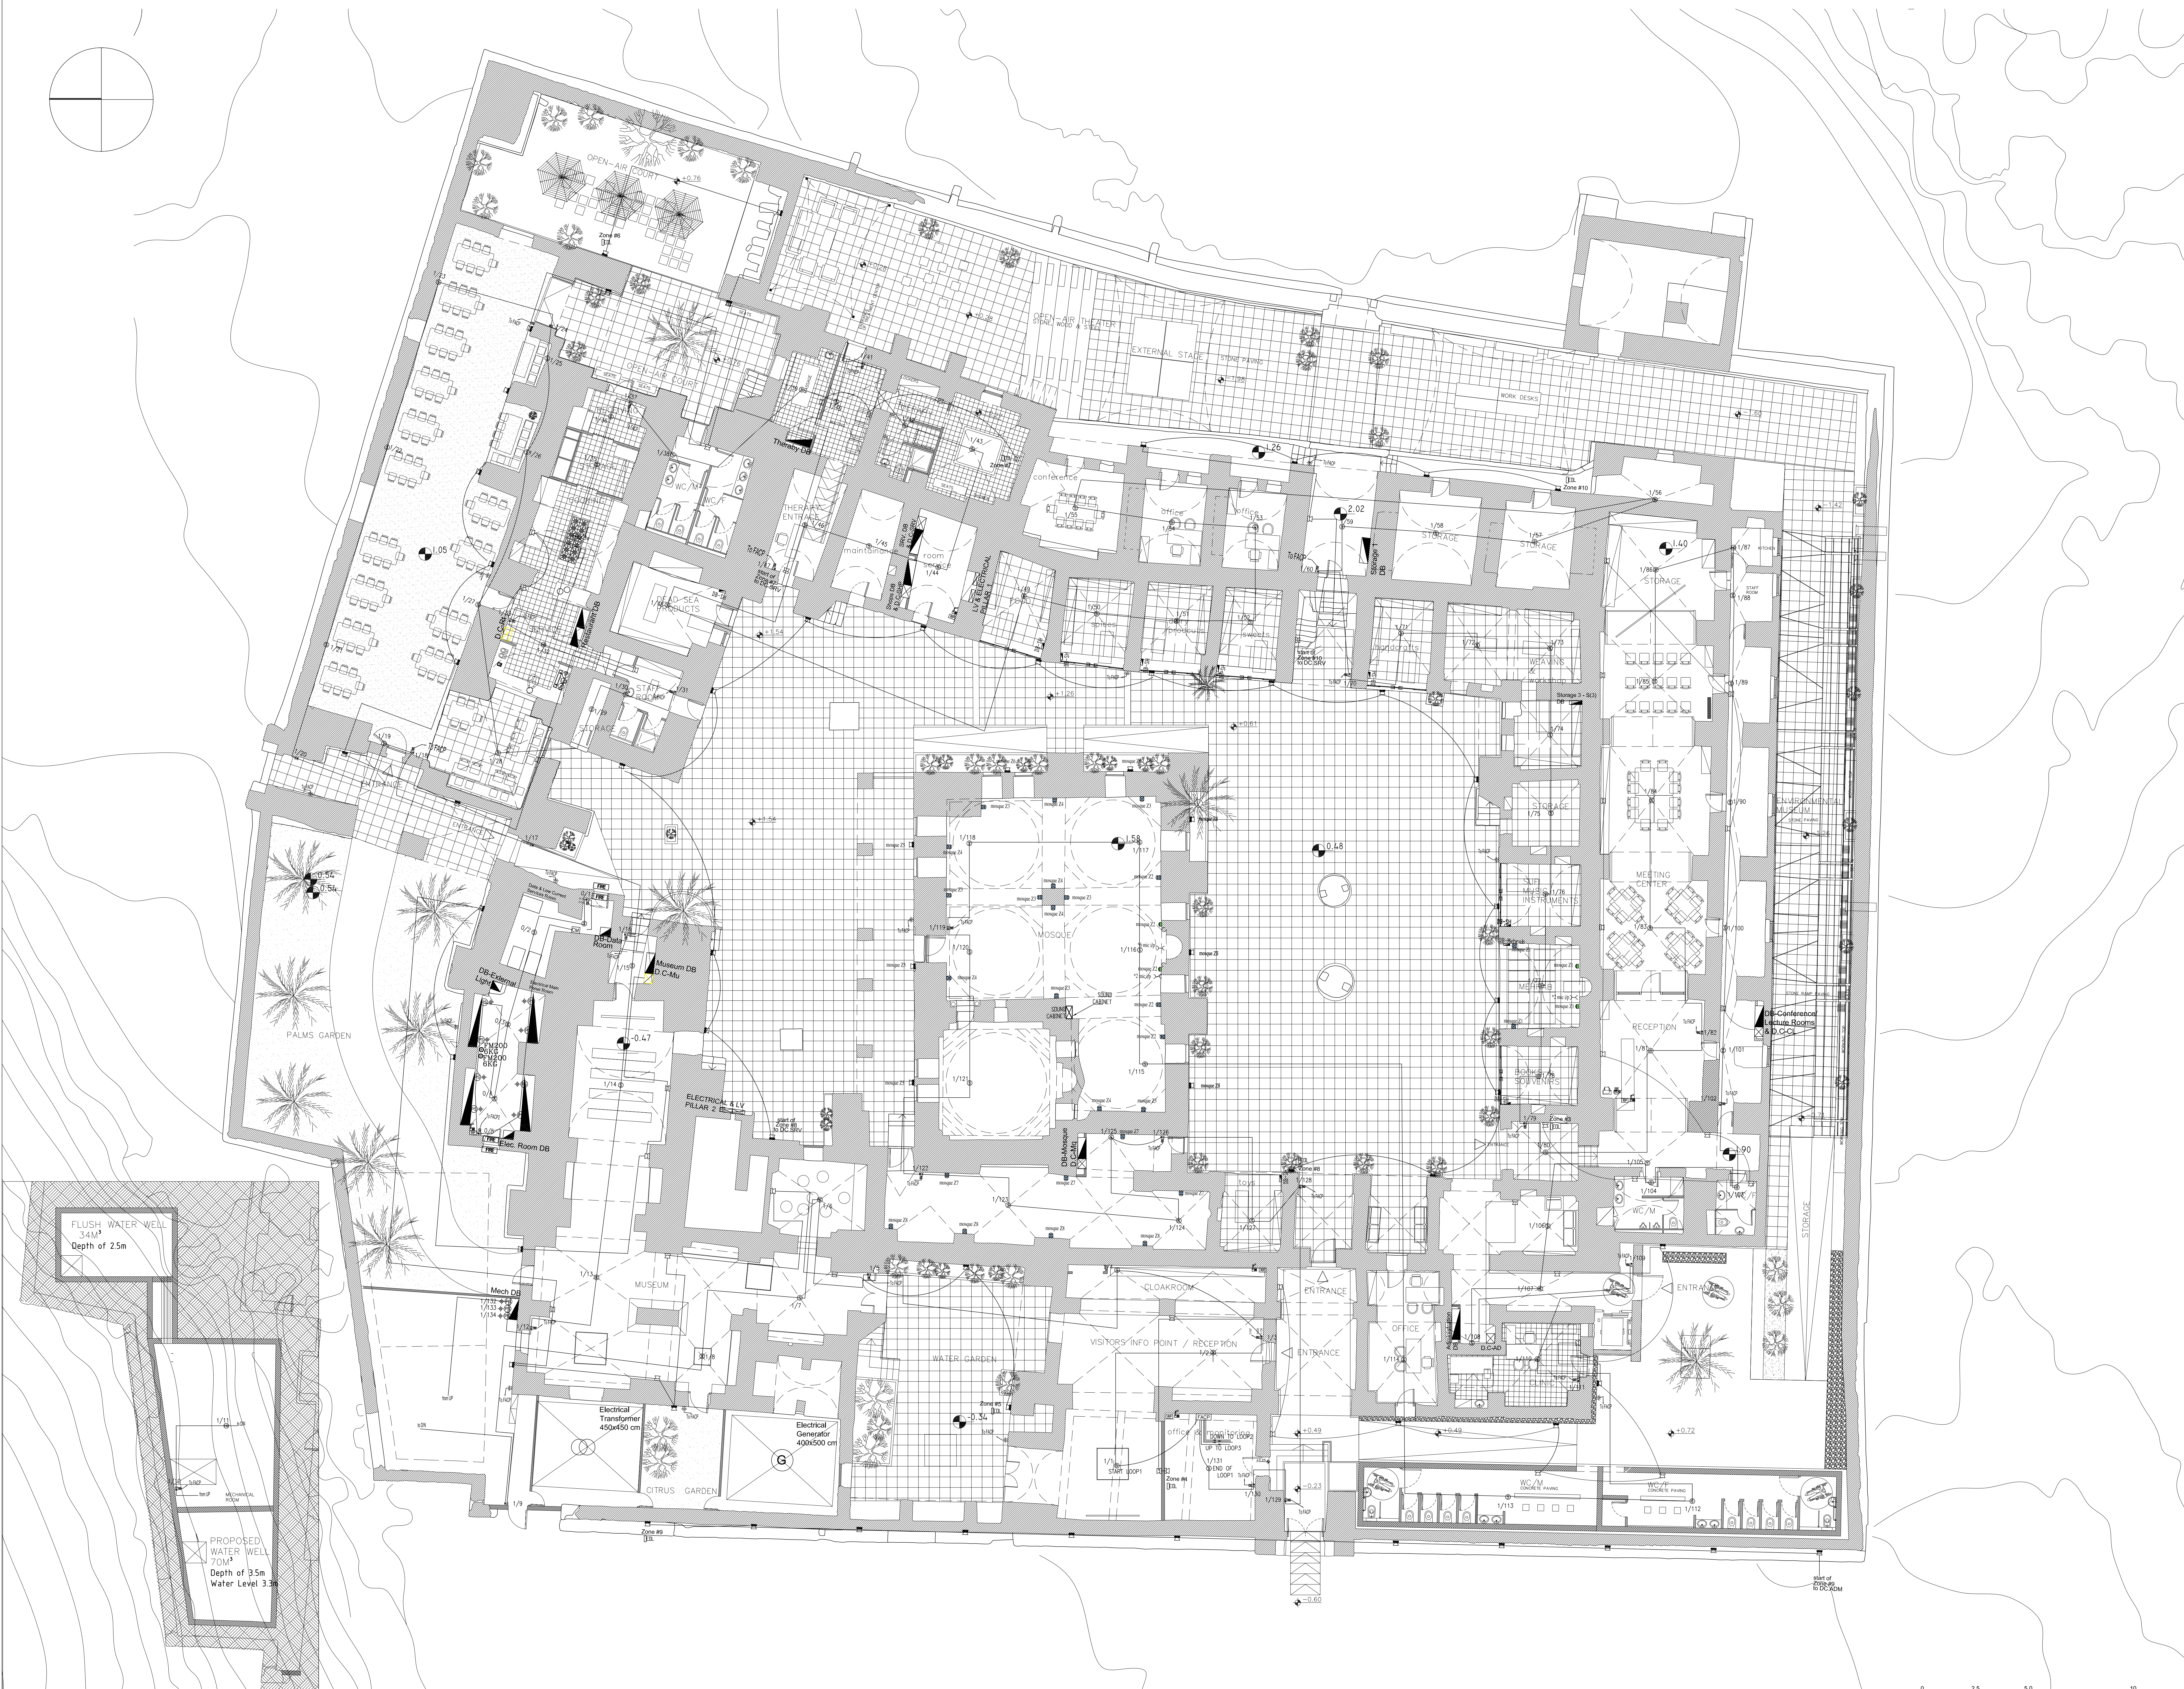

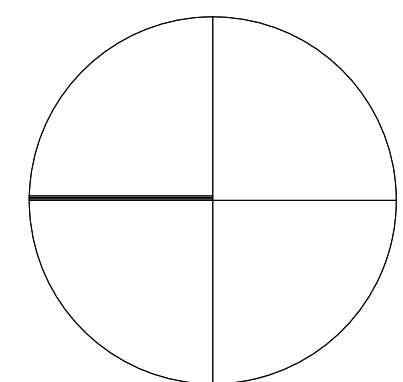

NOTES & LEGEND:

SYMBOL	DESCRIPTION	
	POWER SOCKETS	H= (cm) 0.15
	16A 3 PIN SOCKET OUTLET / W.P.	180
	16A 3 PIN SOCKET OUTLET CEILING MOUNTED	180
	16A 3 PIN TRIP SOCKET OUTLET / W.P.	180
	16A 3 PIN TRIP SOCKET OUTLET	180
	SINGLE PHASE (3POLE) ISOLATOR, Rate As Indicated	220
	THREE PHASE (4POLE) ISOLATOR, Rate As Indicated	220
	JUNCTION BOX	160
	EMERGENCY TRIP PUSH BUTTON	220
	THERMOSTAT	160
	3 PHASE SOCKET	150
	3 PHASE SOCKET INTERLOCKED	
	W.P. 16A 3 PIN SOCKET OUTLET WITH DOUBLE POLE SWITCH WITH INDICATOR LAMP	
	Double UPS socket	

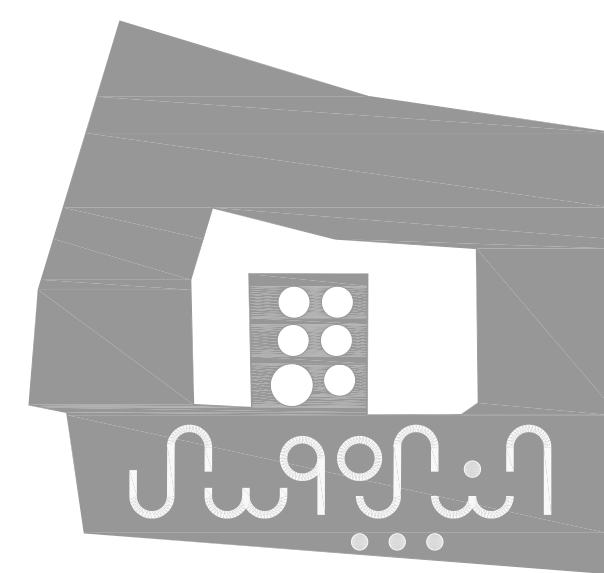

PROJECT:

Securing Professional Services for the Architectural Restoration and Rehabilitation Designs, Archaeological Documentation and Orientation Training, Including Tender Documents Preparation and Site Supervision for Conservation and Rehabilitation Works of Maqam Al-Nabi Musa in Jericho Governorate

Support to Development of Cultural Tourism

DESIGN WORKS:

-Jerusalem Design Center

ELECTRICAL WORKS:

-Eng. Midhat AlSharif

MECHANICAL WORKS:

-Elite Mechanical Consultants

SHEET NAME:

Ground Floor
Electromechanical System

SCALE: 1:100

if plotted on A0

For Review

For Approval

For Tender

For Construction

DATE: July-2016


SHEET NO.

E-13

DATE: July-2016


Jerusalem Design Center
Architects, Engineers & Consultants

Phone: 02 234 3696 | Fax: 02 234 3718 | Email: info@jdc.gov.ps

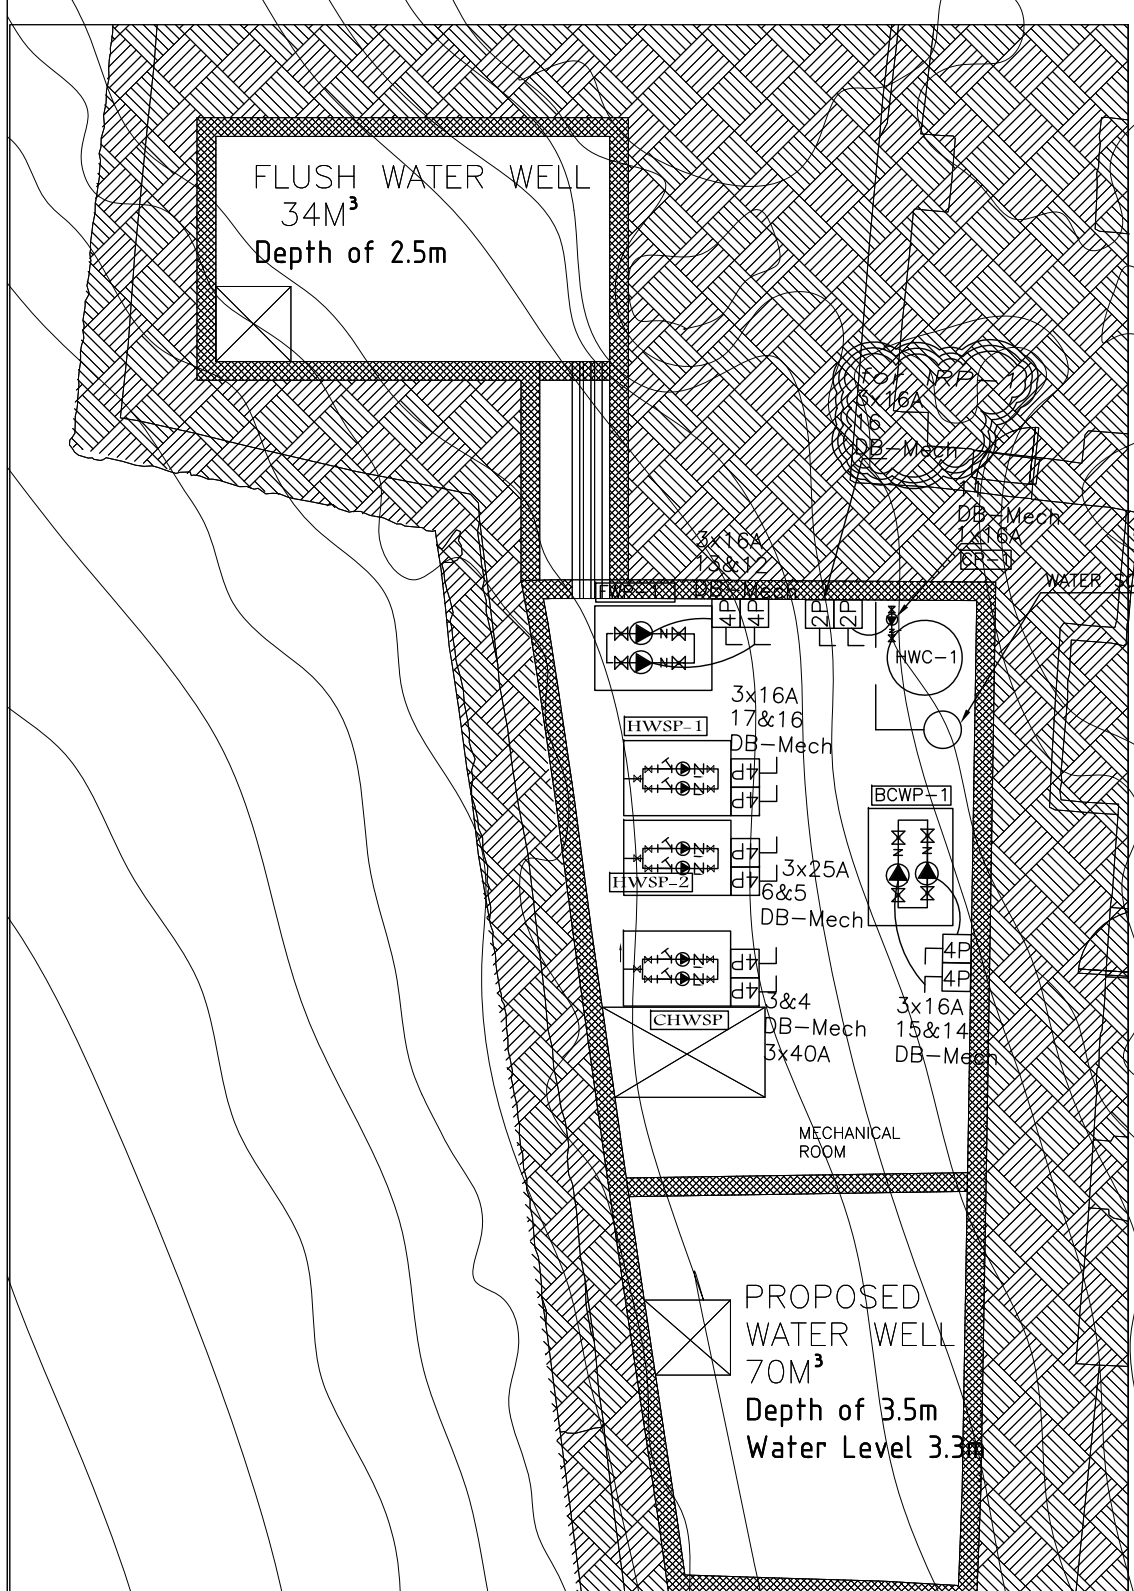


UNDERGROUND

0 2.5 5.0 10

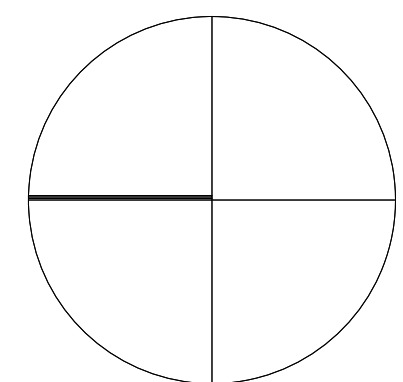

NOTES & LEGEND:

SYMBOL	DESCRIPTION
	THREE/SINGLE PHASE
	MAIN ELECTRIC BOARD LV. SIDE
	METAL ELECTRIC BOARD WITH LOW VOLTAGE SIDE
	DISTRIBUTION BOARD
	GENERATOR
	STEP RELAY
	MOTORIZED AIR CIRCUIT BREAKER WITH TRIP RATING
	CONTACTOR
	INDICATOR LAMPS WITH PUSH BUTTON
	GENERAL MULTIMETER
	AMETER/VOLTMETER
	TRANSFORMER
	THREE/SINGLE PHASE FUSE
	THREE/SINGLE PHASE EARTH LEAKAGE RELAY
	THREE PHASE kWhm
	SINGLE PHASE kWhm
	4-POLE CHANGE OVER SWITCH MANUAL OR AUTO
	CHECK BOX
	60*60CM ELECTRICAL MANHOLE
	60*60CM TELEPHONE MANHOLE

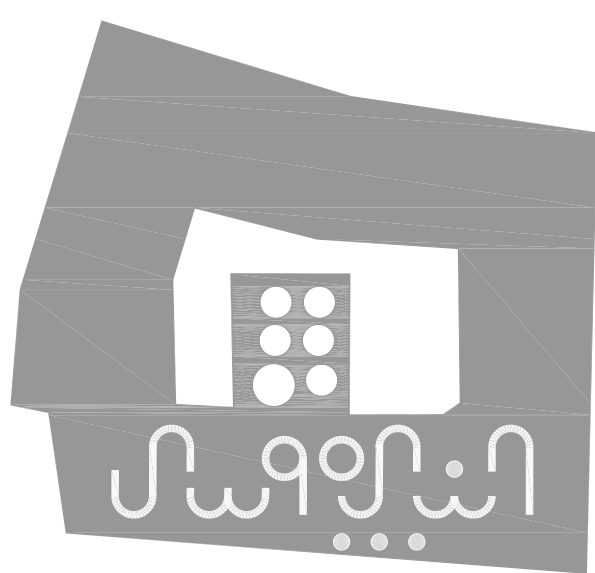

PROJECT:

Securing Professional Services for the Architectural Restoration and Rehabilitation Designs, Archaeological Documentation and Orientation Training, Including Tender Documents Preparation and Site Supervision for Conservation and Rehabilitation Works of Maqam Al-Nabi Musa in Jericho Governorate

Support to Development of Cultural Tourism

DESIGN WORKS:

-Jerusalem Design Center

ELECTRICAL WORKS:

-Eng .Midhat AlSharif

MECHANICAL WORKS:

-Elite Mechanical Consultants

SHEET NAME:

First Floor
MAIN FEEDER LINES

SCALE: 1:100

if plotted on A0

For Review

For Approval

For Tender

For Construction

DATE: July-2016

 
EDITION:



SHEET NO.

E-14




DESIGN



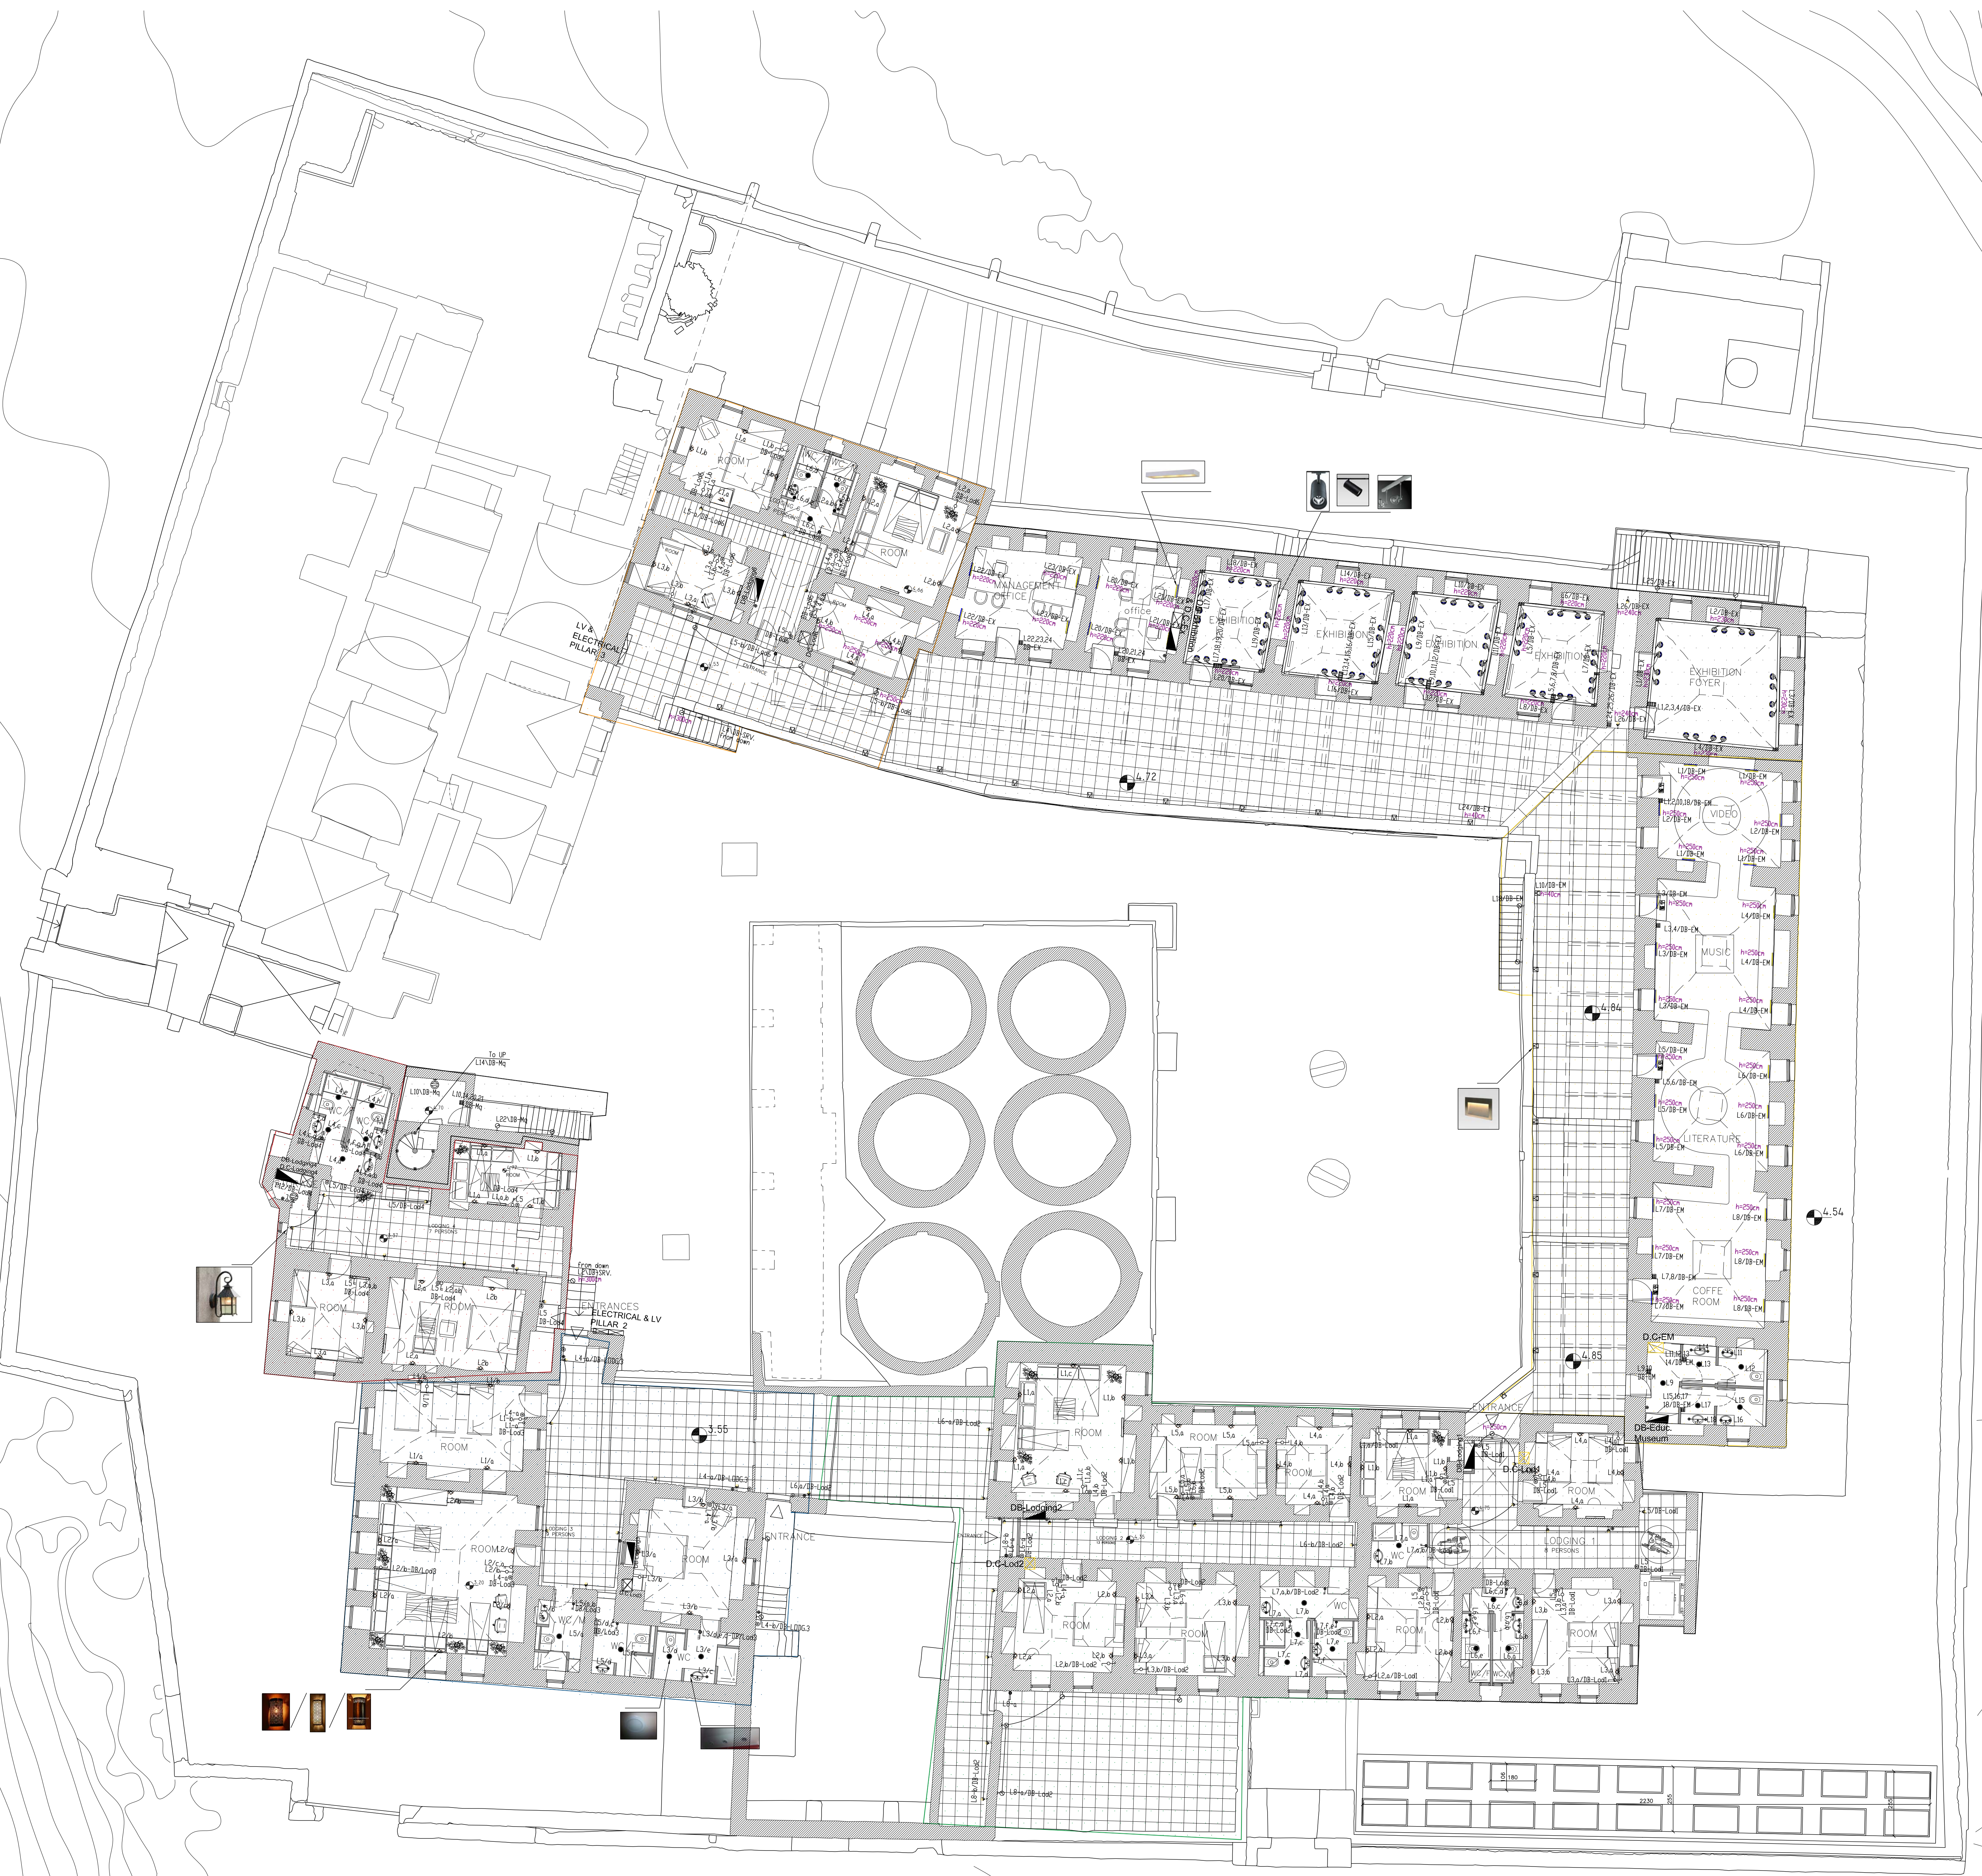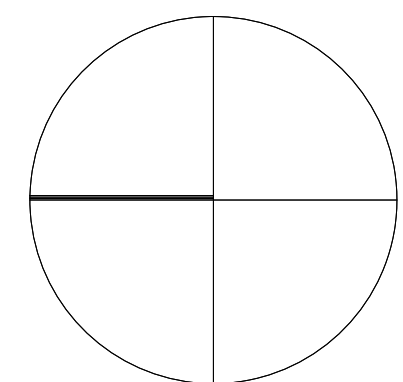


 Note : Lighting Fixtures images for lighting concept & indication only



NOTES & LEGEND:

SYMBOL	DESCRIPTION
LIGHTING FIXTURE & SWITCHES	
	Type 1 Lighting For Lodging Rooms
	Type 2 Lighting For Corridor Lodging
	Type 3 Lighting For Chandelier Moslem Mosque
	Type 4 Lighting For Chandelier For the Mosque
	Type 5 Lighting For Moslem Mosque
	Type 6 Wall Recessed led for hallway For the Mosquet of the Mosque
	Type 7 Wall mounted lighting fixture updown light
	Type 8 Lighting For Storage
	Type 9 Wall Recessed Light 3 Watt LED
	Type 10 Wall Recessed 3 Watt Led
	Type 11 LED type with red sign and arrows emergency lighting EX.
	Type 12 LED FLOOR SPOT 2W IP 65
	Type 13 Lighting For Restaurant
	Type 14 Lighting For Restaurant
	Type 15 Lighting For Restaurant
	Type 16 18W LED, FALSE ceiling recessed lighting fixture
	Type 17 Recessed down light 18W LED with Polycarbonate Lens
	Type 18 2x20W T5 Ceiling Mount V.P. Fluorescent
	Type 19 Lighting For Shop
	Type 20 Lighting For Office Up/In
	Type 21 Multi Directional Spot Lighting For Exhibitions
	Type 22 directional spot Lighting
	Type 23 Lighting For Entrance
	Type 24 18 watt LED wall mount appl. IP65 fixture
	Type 25 Lighting For Outer Wall Warm white LED 15Watt
	Type 26 Lighting For External Gate
	Type 27 Waterproof Led Strip
	Type 28 Switch LED type emergency Lighting Int. 90 min. Electromech. or G5
	Type 29 Lighting Plan For Outside Area
	Type 30 Smart switch for 2 ways
	Type 31 Smart switch for 4 ways
	Type 32 Smart switch for 8 ways
	Type 33 PUSH BUTTON
	Type 34 SINGLE POLE ONE GANG SWITCH / W.P.
	Type 35 SINGLE POLE TWO GANG SWITCH / W.P.
	Type 36 SINGLE POLE THREE GANG SWITCH / W.P.
	Type 37 TWO WAY SWITCH / W.P.

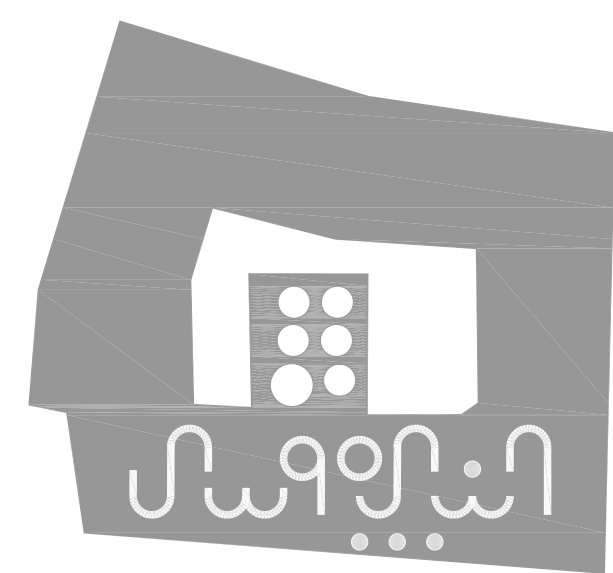

PROJECT:
Securing Professional Services for the Architectural Restoration and Rehabilitation Designs, Archaeological Documentation and Orientation Training, Including Tender Documents Preparation and Site Supervision for Conservation and Rehabilitation Works of Maqam Al-Nabi Musa in Jericho Governorate
Support to Development of Cultural Tourism

DESIGN WORKS:
-Jerusalem Design Center

 


ELECTRICAL WORKS:
-Eng .Midhat AlSharif

MECHANICAL WORKS:
-Elite Mechanical Consultants


SHEET NAME:
First Floor
Lighting System

SCALE: 1:100
if plotted on A0
☐ For Review
☐ For Approval
☒ For Tender
☐ For Construction
DATE: July-2016
EDITION:
SHEET NO.
E-15



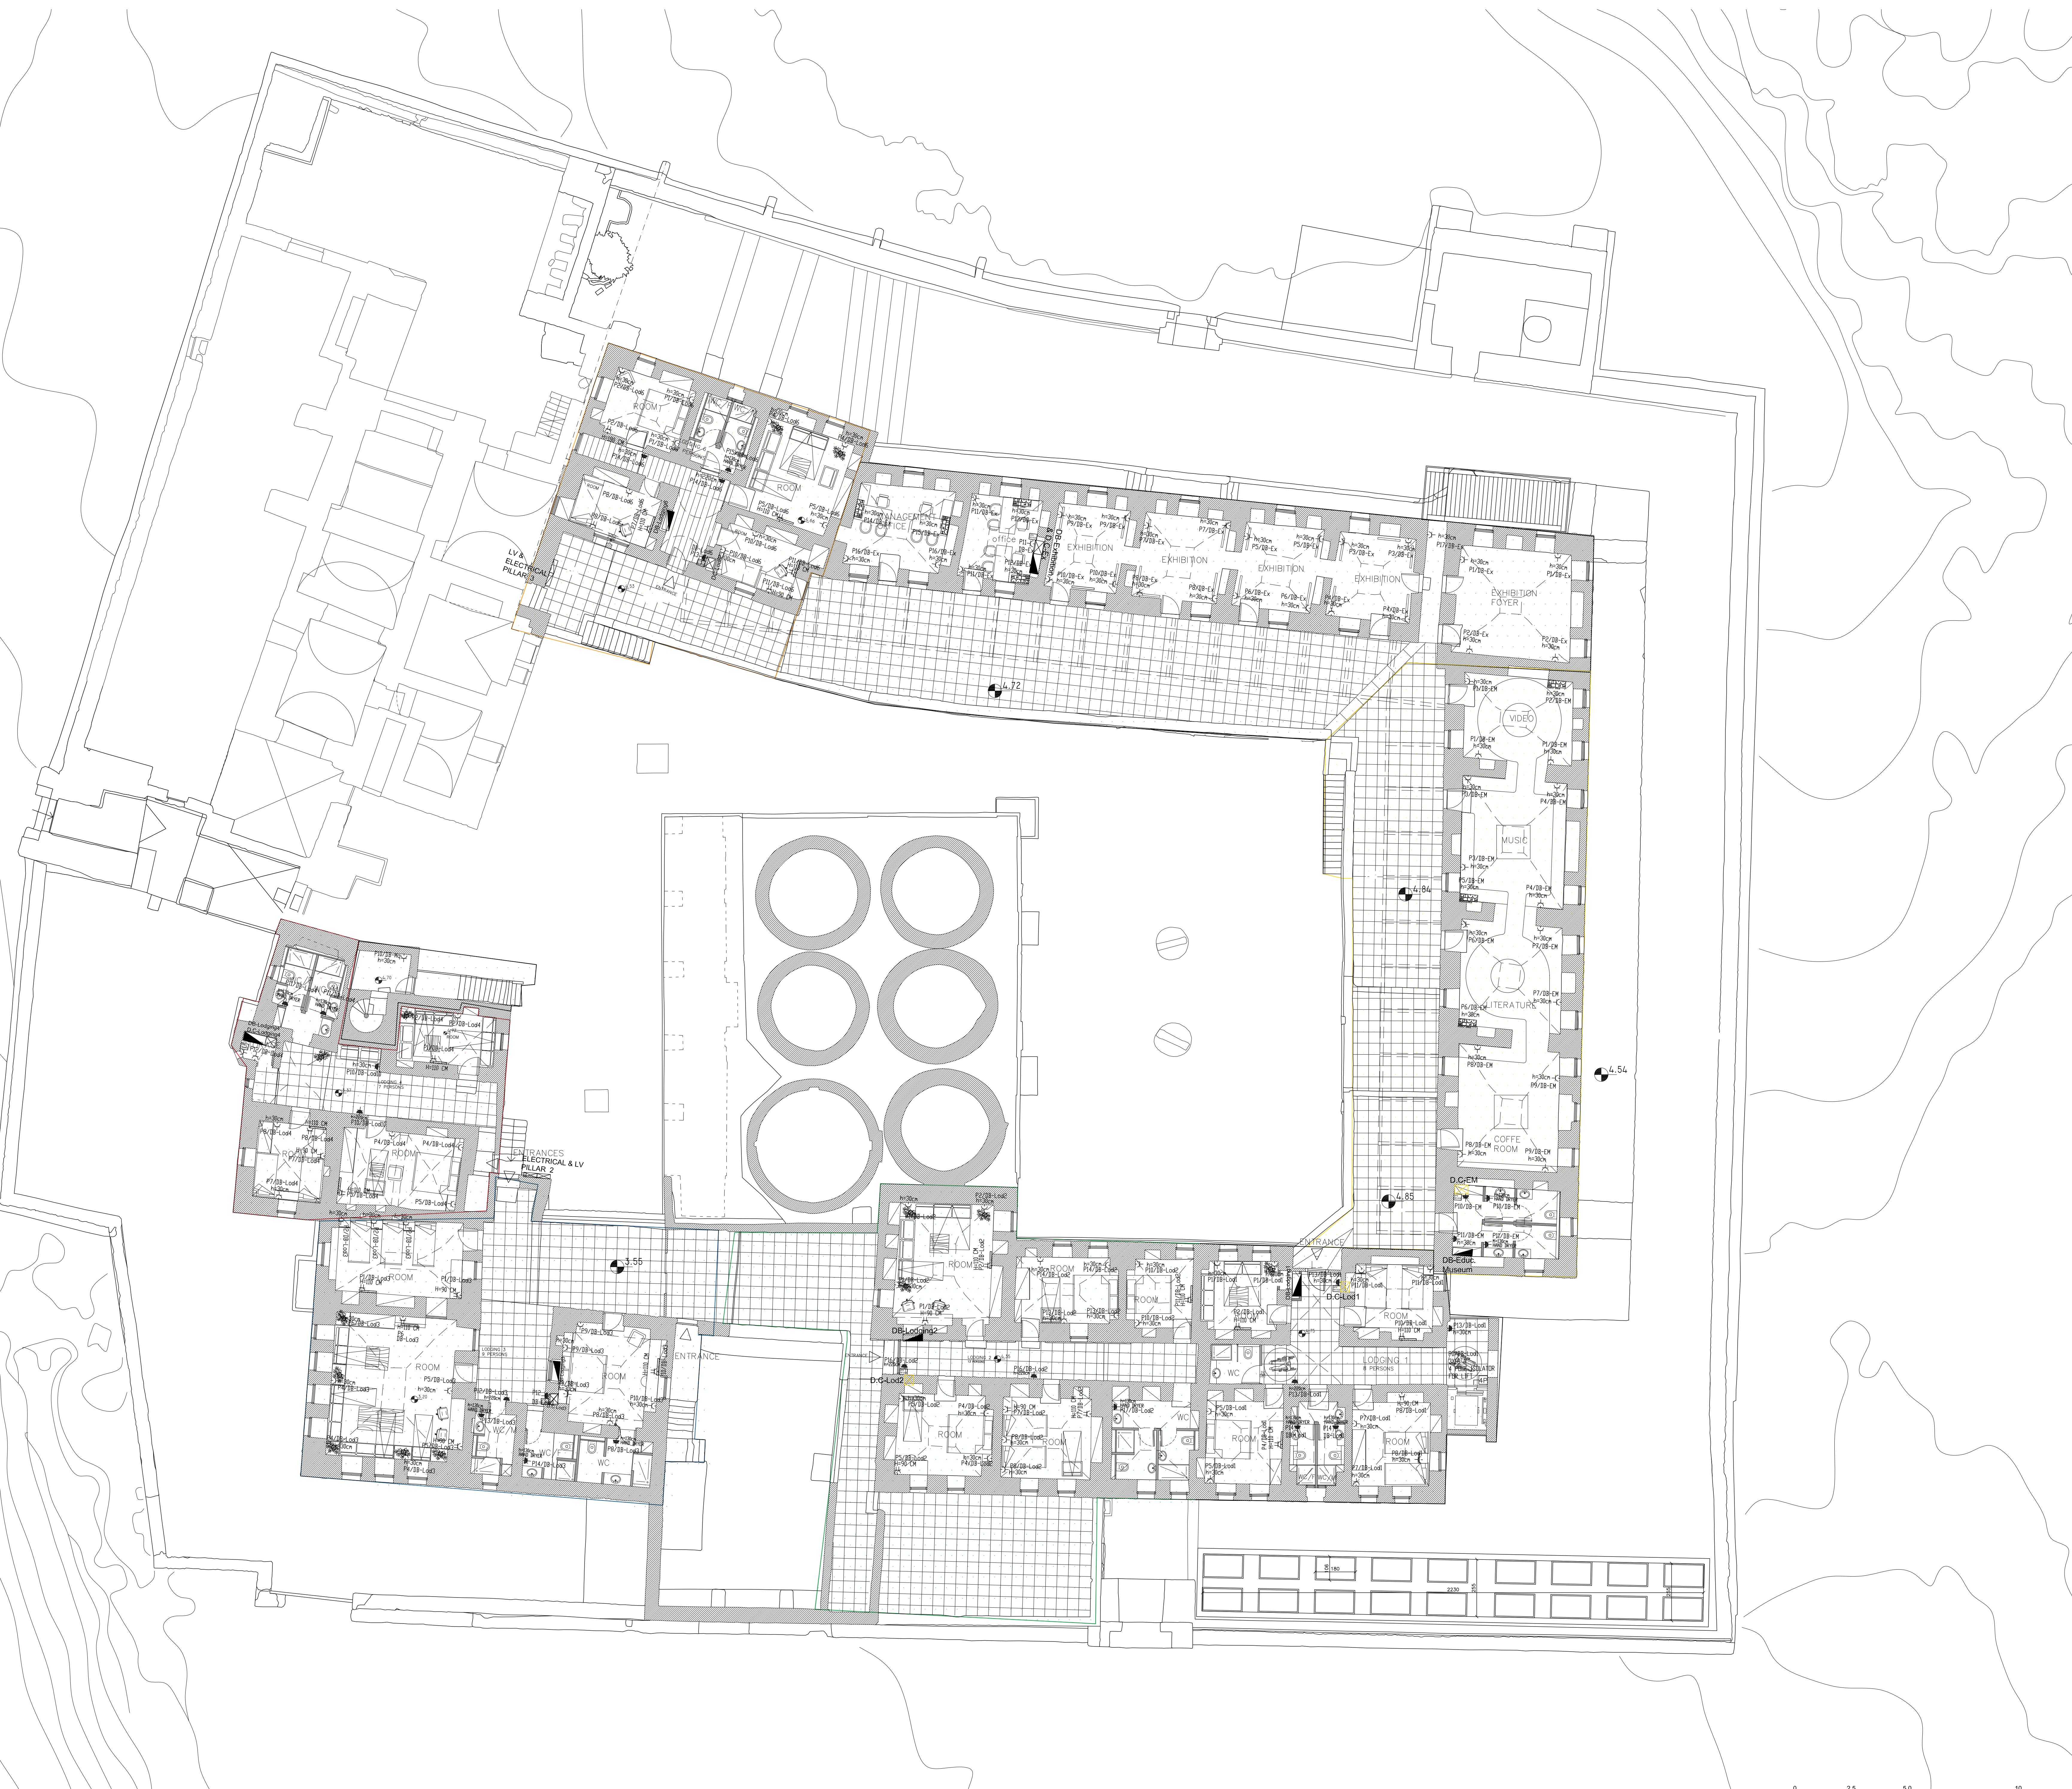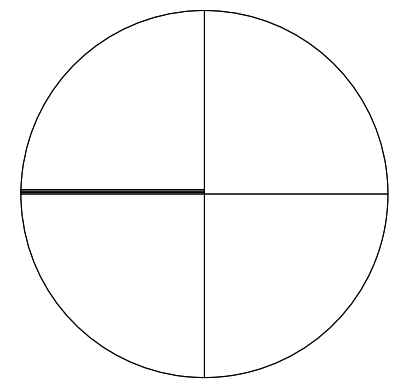

NOTES & LEGEND:		
SYMBOL	DESCRIPTION	
POWER SOCKETS		
	16A 3 PIN SOCKET OUTLET / W.P.	180
	16A 3 PIN SOCKET OUTLET CEILING MOUNTED	180
	16A 3 PIN TRIP SOCKET OUTLET / W.P.	180
	16A 3 PIN TRIP SOCKET OUTLET	180
	SINGLE PHASE (2POLE) ISOLATOR, Rate As Indicated	220
	THREE PHASE (4POLE) ISOLATOR, Rate As Indicated	220
	JUNCTION BOX	160
	EMERGENCY TRIP PUSH BUTTON	220
	THERMOSTAT	160
	3 PHASE SOCKET	150
	W.P. 16A 3 PIN SOCKET OUTLET WITH DOUBLE POLE SWITCH WITH INDICATOR LAMP	
	Double UPS socket	

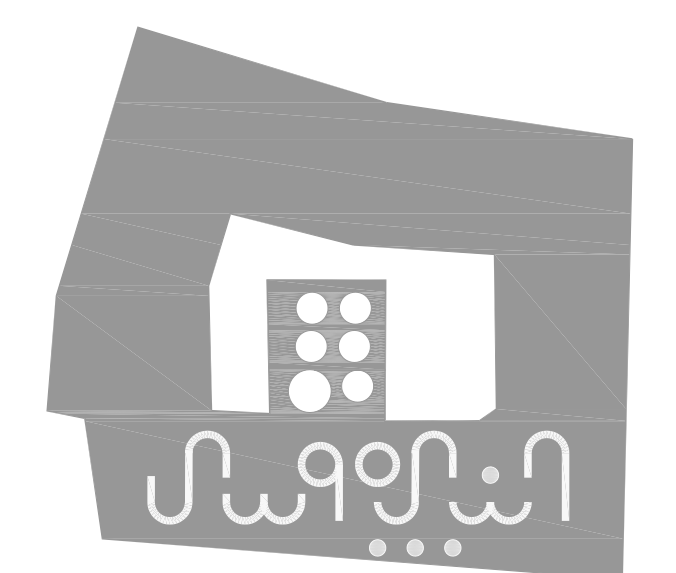

PROJECT:

Securing Professional Services for the Architectural Restoration and Rehabilitation Designs, Archaeological Documentation and Orientation Training, Including Tender Documents Preparation and Site Supervision for Conservation and Rehabilitation Works of Maqam Al-Nabi Musa in Jericho Governorate

Support to Development of Cultural Tourism

DESIGN WORKS:

-Jerusalem Design Center

ELECTRICAL WORKS:

-Eng .Midhat AlSharif



MECHANICAL WORKS:

-Elite Mechanical Consultants

SHEET NAME:


First Floor
Power Systems

SCALE: 1:100 if plotted on A0	EDITION:
☐ For Review	SHEET NO.
☐ For Approval	
☒ For Tender	
☐ For Construction	
DATE: July-2016	

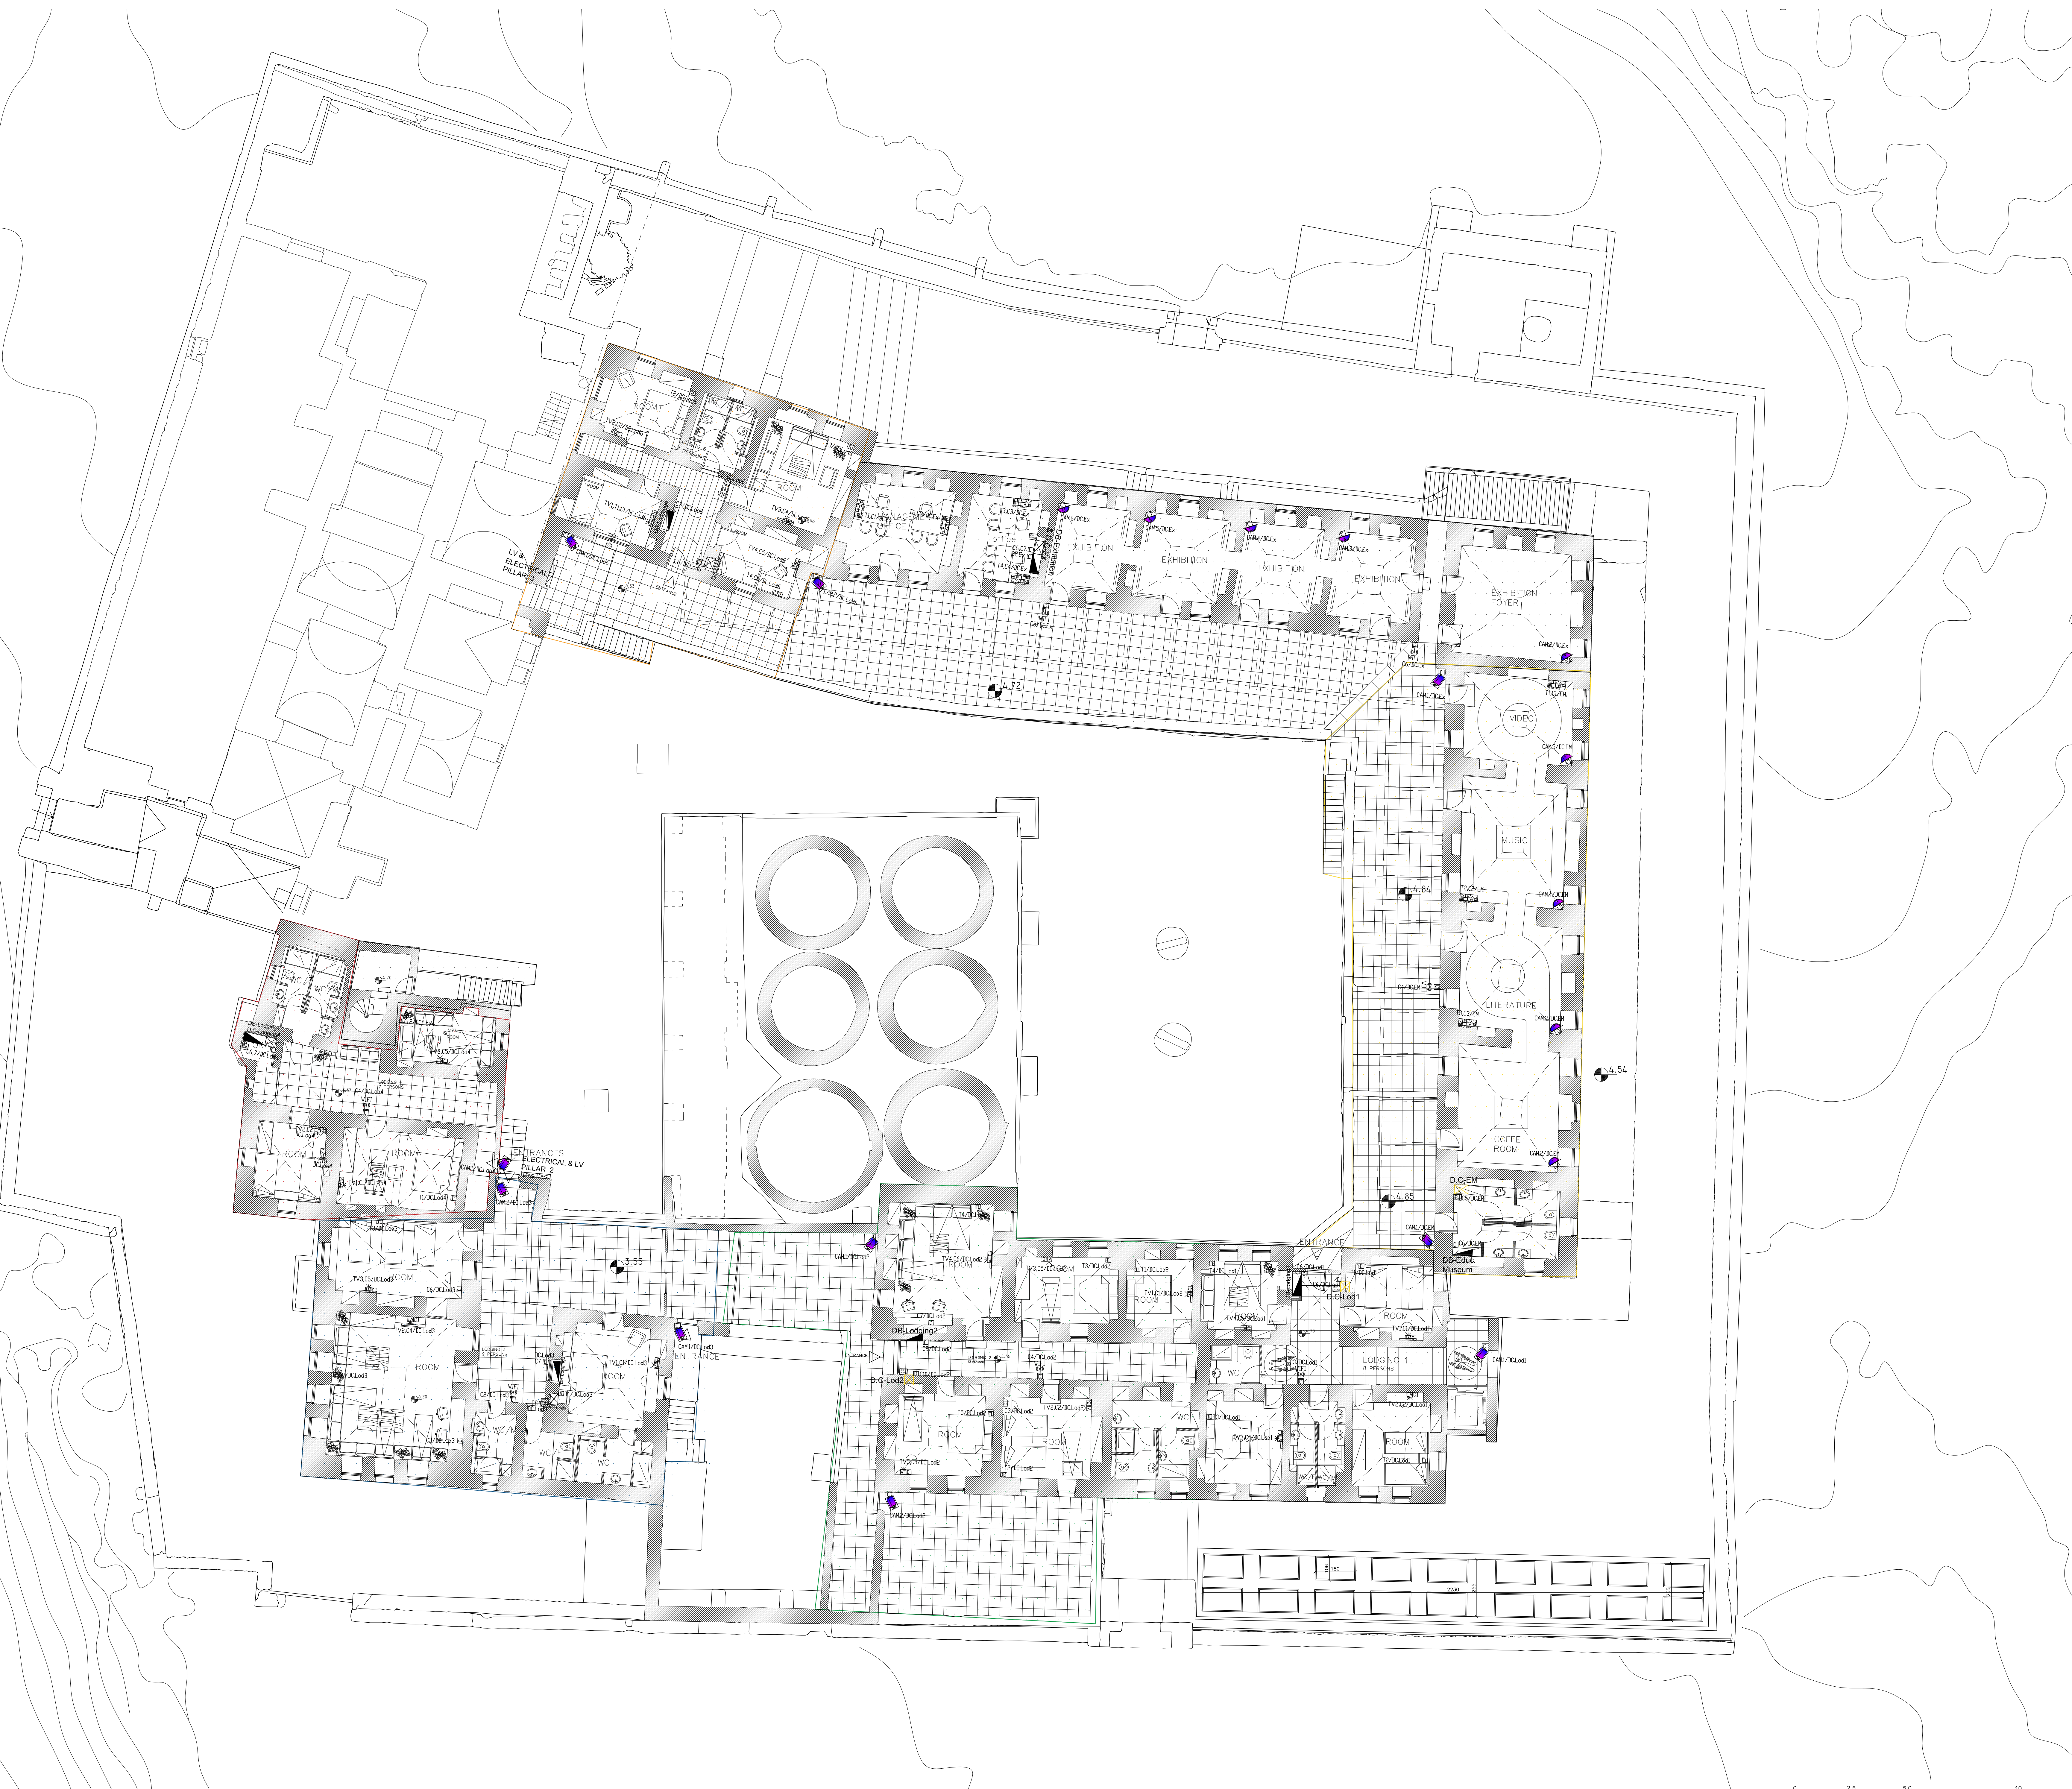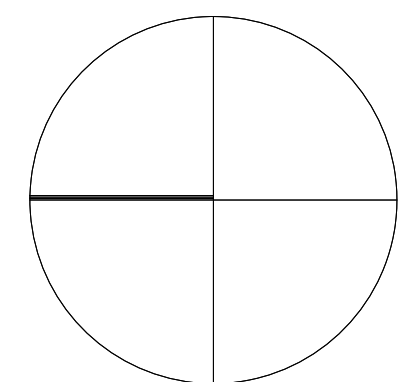

NOTES & LEGEND:

SYMBOL	DESCRIPTION
	L.V. SOCKETS
	TELEPHONE SOCKET OUTLET
	D.V. SOCKET OUTLET
	DATA SOCKET OUTLET
	LOW VOLTAGE BOX
	COMPUTER PATCH PANEL
	INTERCOM
	Wi-Fi Point
	Data Cabinet
	PROJECTOR
	CCTV SYSTEM
	30M INDOOR COLORED CAMERA
	FIXED OUTDOOR COLORED CAMERA DAY/NIGHT
	SPLIT SCREEN MONITOR
	CCTV CENTRAL MONITOR

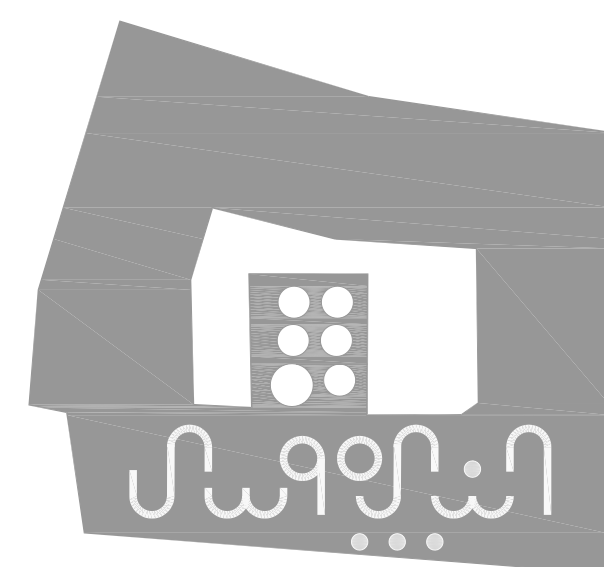

PROJECT:

Securing Professional Services for the Architectural Restoration and Rehabilitation Designs, Archaeological Documentation and Orientation Training, Including Tender Documents Preparation and Site Supervision for Conservation and Rehabilitation Works of Maqam Al-Nabi Musa in Jericho Governorate

Support to Development of Cultural Tourism

DESIGN WORKS:

-Jerusalem Design Center

ELECTRICAL WORKS:

-Eng .Midhat AlSharif

MECHANICAL WORKS:

-Elite Mechanical Consultants

SHEET NAME:

First Floor
LV Systems

SCALE: 1:100
if plotted on A0

EDITION:

For Review

For Approval

☒ For Tender

For Construction


DATE: July-2016

SHEET NO.

E-17

JerusalemDesignCenter
Architects, Engineers & Consultants


Phone: 02 234 3696 | Fax: 02 234 3710 | Email: info@jdc.ps

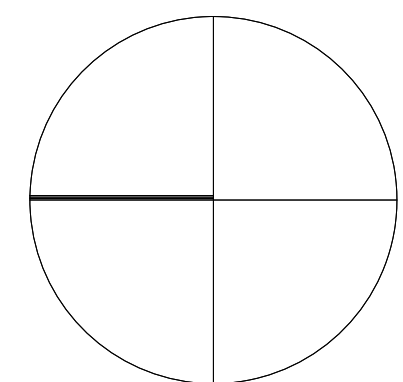

NOTES & LEGEND:

SYMBOL	DESCRIPTION
FIRE ALARM SYSTEM	
⊙	PHOTO SMOKE SENSOR
⊙	HEAT DETECTOR
M.S.G.	BREAK GLASS
⊙	INTERVAL SIREN
⊙	CONTROL MODULE
⊙	EXTERNAL SIREN WITH FLASHER
⊙	Beam Detector-Receiver
⊙	Beam Detector-Transmitter
+	DETECTOR INDICATION LAMP
⊙	PHOTOELECTRIC SMOKE DET. ABOVE FAULSCEILING
FACP	FIRE ALARM CONTROL PANEL
RP	REPEATER PANEL WITH CONTROL
⊙	FIRE INDICATOR LAMP SIGN

SYMBOL	DESCRIPTION	Hz (cm) a.H.
SOUND SYSTEM		
⊙	6WATT RECESSED LOUD SPEAKER	CEILING
⊙	6WATT SURFACE MOUNT LOUD SPEAKER	220
⊙	25W WALL MOUNTED ADJUSTABLE HORN	220
⊙	END OF THE LINE	CEILING
⊙	VOLUME CONTROL	150
⊙	16 BUTTON CALL STATION	Table
⊙	PUBLIC ADDRESS AND VOICE ALARM BACK	180
⊙	PENDANT SPEAKER	
⊙	CEILING SPEAKER	
⊙	WALL MOUNT SPEAKER	
⊙	COLUMN SPEAKER 0.5M	
⊙	COLUMN SPEAKER 1.0M	
⊙	HORN SPEAKER	
⊙	Horn speaker 2 way	
⊙	Microphone XLR box	
⊙	Zone No.	
⊙	42 U rack cabinet	

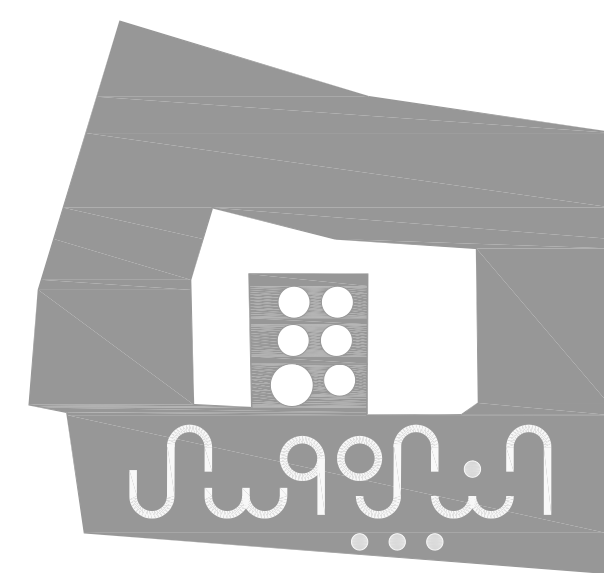

PROJECT:

Securing Professional Services for the Architectural Restoration and Rehabilitation Designs, Archaeological Documentation and Orientation Training, Including Tender Documents Preparation and Site Supervision for Conservation and Rehabilitation Works of Maqam Al-Nabi Musa in Jericho Governorate

Support to Development of Cultural Tourism

DESIGN WORKS:

-Jerusalem Design Center

ELECTRICAL WORKS:

-Eng .Midhat AlSharif

MECHANICAL WORKS:

-Elite Mechanical Consultants

SHEET NAME:
First Floor
Fire Alarm & Public
Address Systems

SCALE: 1:100
if plotted on A0

☐ For Review
☐ For Approval
☒ For Tender
☐ For Construction

DATE: July-2016




EDITION:

SHEET NO.


E-18



DESIGN

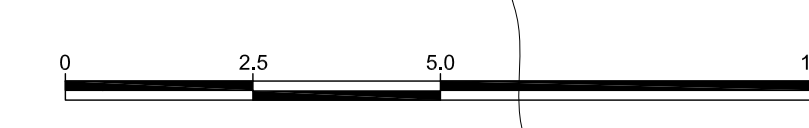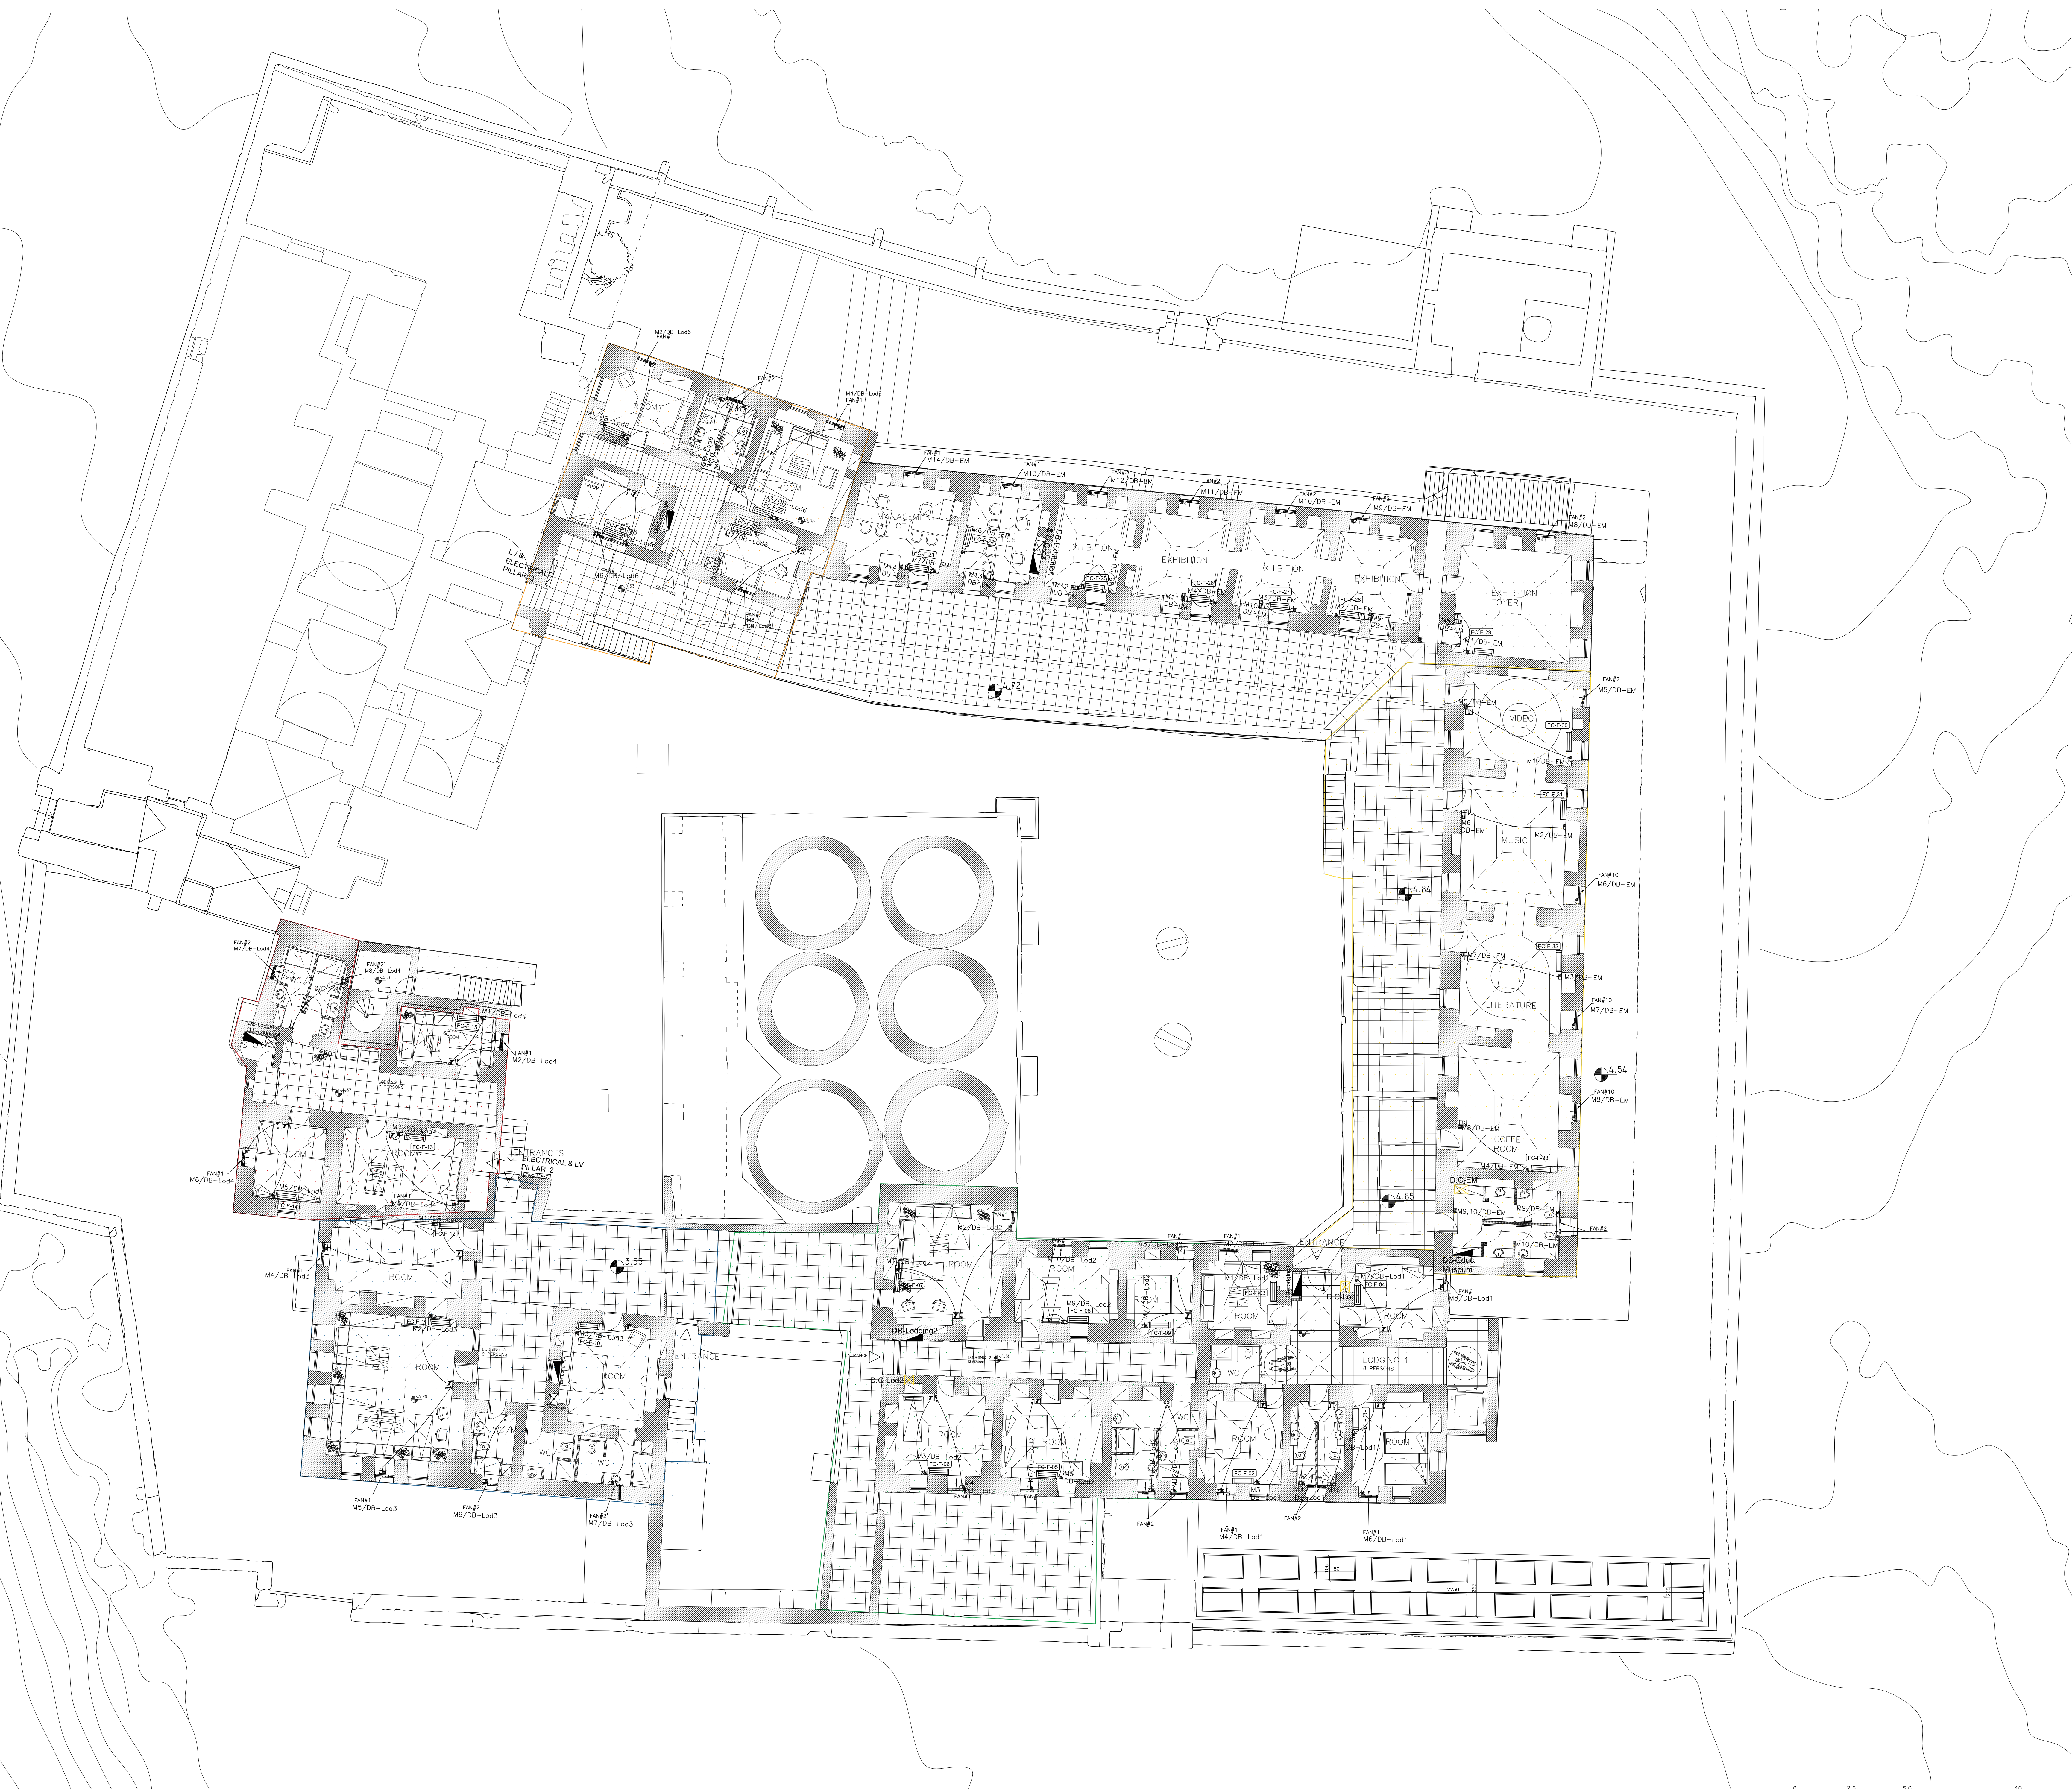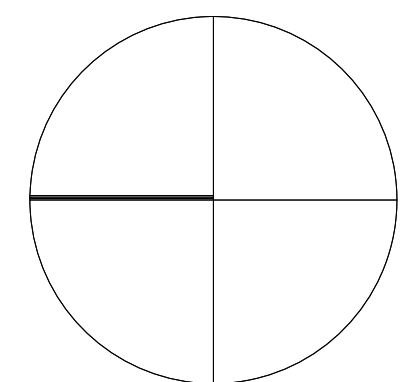

NOTES & LEGEND:		
SYMBOL	DESCRIPTION	
POWER SOCKETS		
		H= (cm) d.f.
	16A 3 PIN SOCKET OUTLET / W.P.	180
	16A 3 PIN SOCKET OUTLET CEILING MOUNTED	180
	16A 3 PIN TRIM SOCKET OUTLET / W.P.	180
	16A 3 PIN TRIPLE SOCKET OUTLET	180
	SINGLE PHASE (2POLE) ISOLATOR, Rate As Indicated	220
	THREE PHASE (4POLE) ISOLATOR, Rate As Indicated	220
	JUNCTION BOX	160
	EMERGENCY TRIP PUSH BUTTON	220
	THERMOSTAT	160
	3 PHASE SOCKET	150
	3 PHASE SOCKET INTERLOCKED	
	W.P. 16A 3 PIN SOCKET OUTLET WITH DOUBLE POLE SWITCH WITH INDICATOR LAMP	
	Double UPS socket	

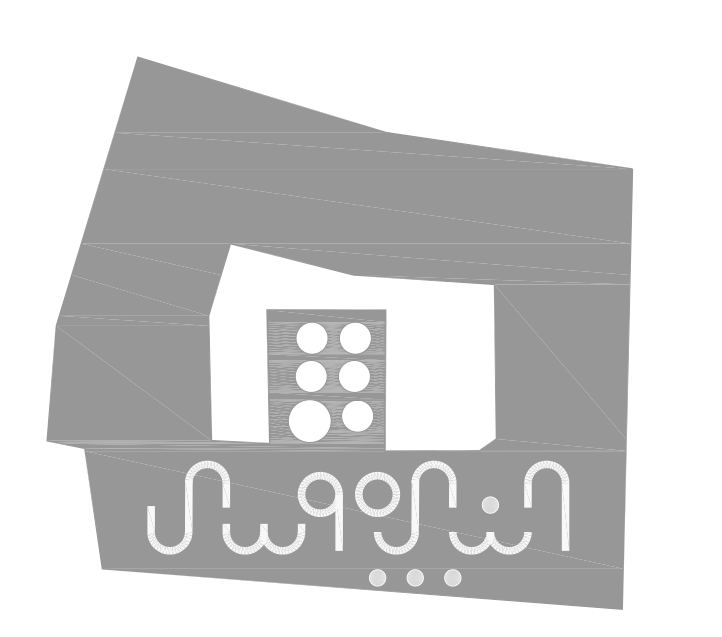

PROJECT:

Securing Professional Services for the Architectural Restoration and Rehabilitation Designs, Archaeological Documentation and Orientation Training, Including Tender Documents Preparation and Site Supervision for Conservation and Rehabilitation Works of Maqam Al-Nabi Musa in Jericho Governorate

Support to Development of Cultural Tourism

DESIGN WORKS:

-Jerusalem Design Center

ELECTRICAL WORKS:

-Eng .Midhat AlSharif




MECHANICAL WORKS:

-Elite Mechanical Consultants

SHEET NAME:


First Floor
Electromechanical System

SCALE: 1:100 if plotted on A0	EDITION:
☐ For Review ☐ For Approval ☒ For Tender ☐ For Construction	SHEET NO.
DATE: July-2016	

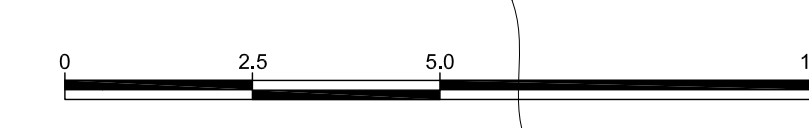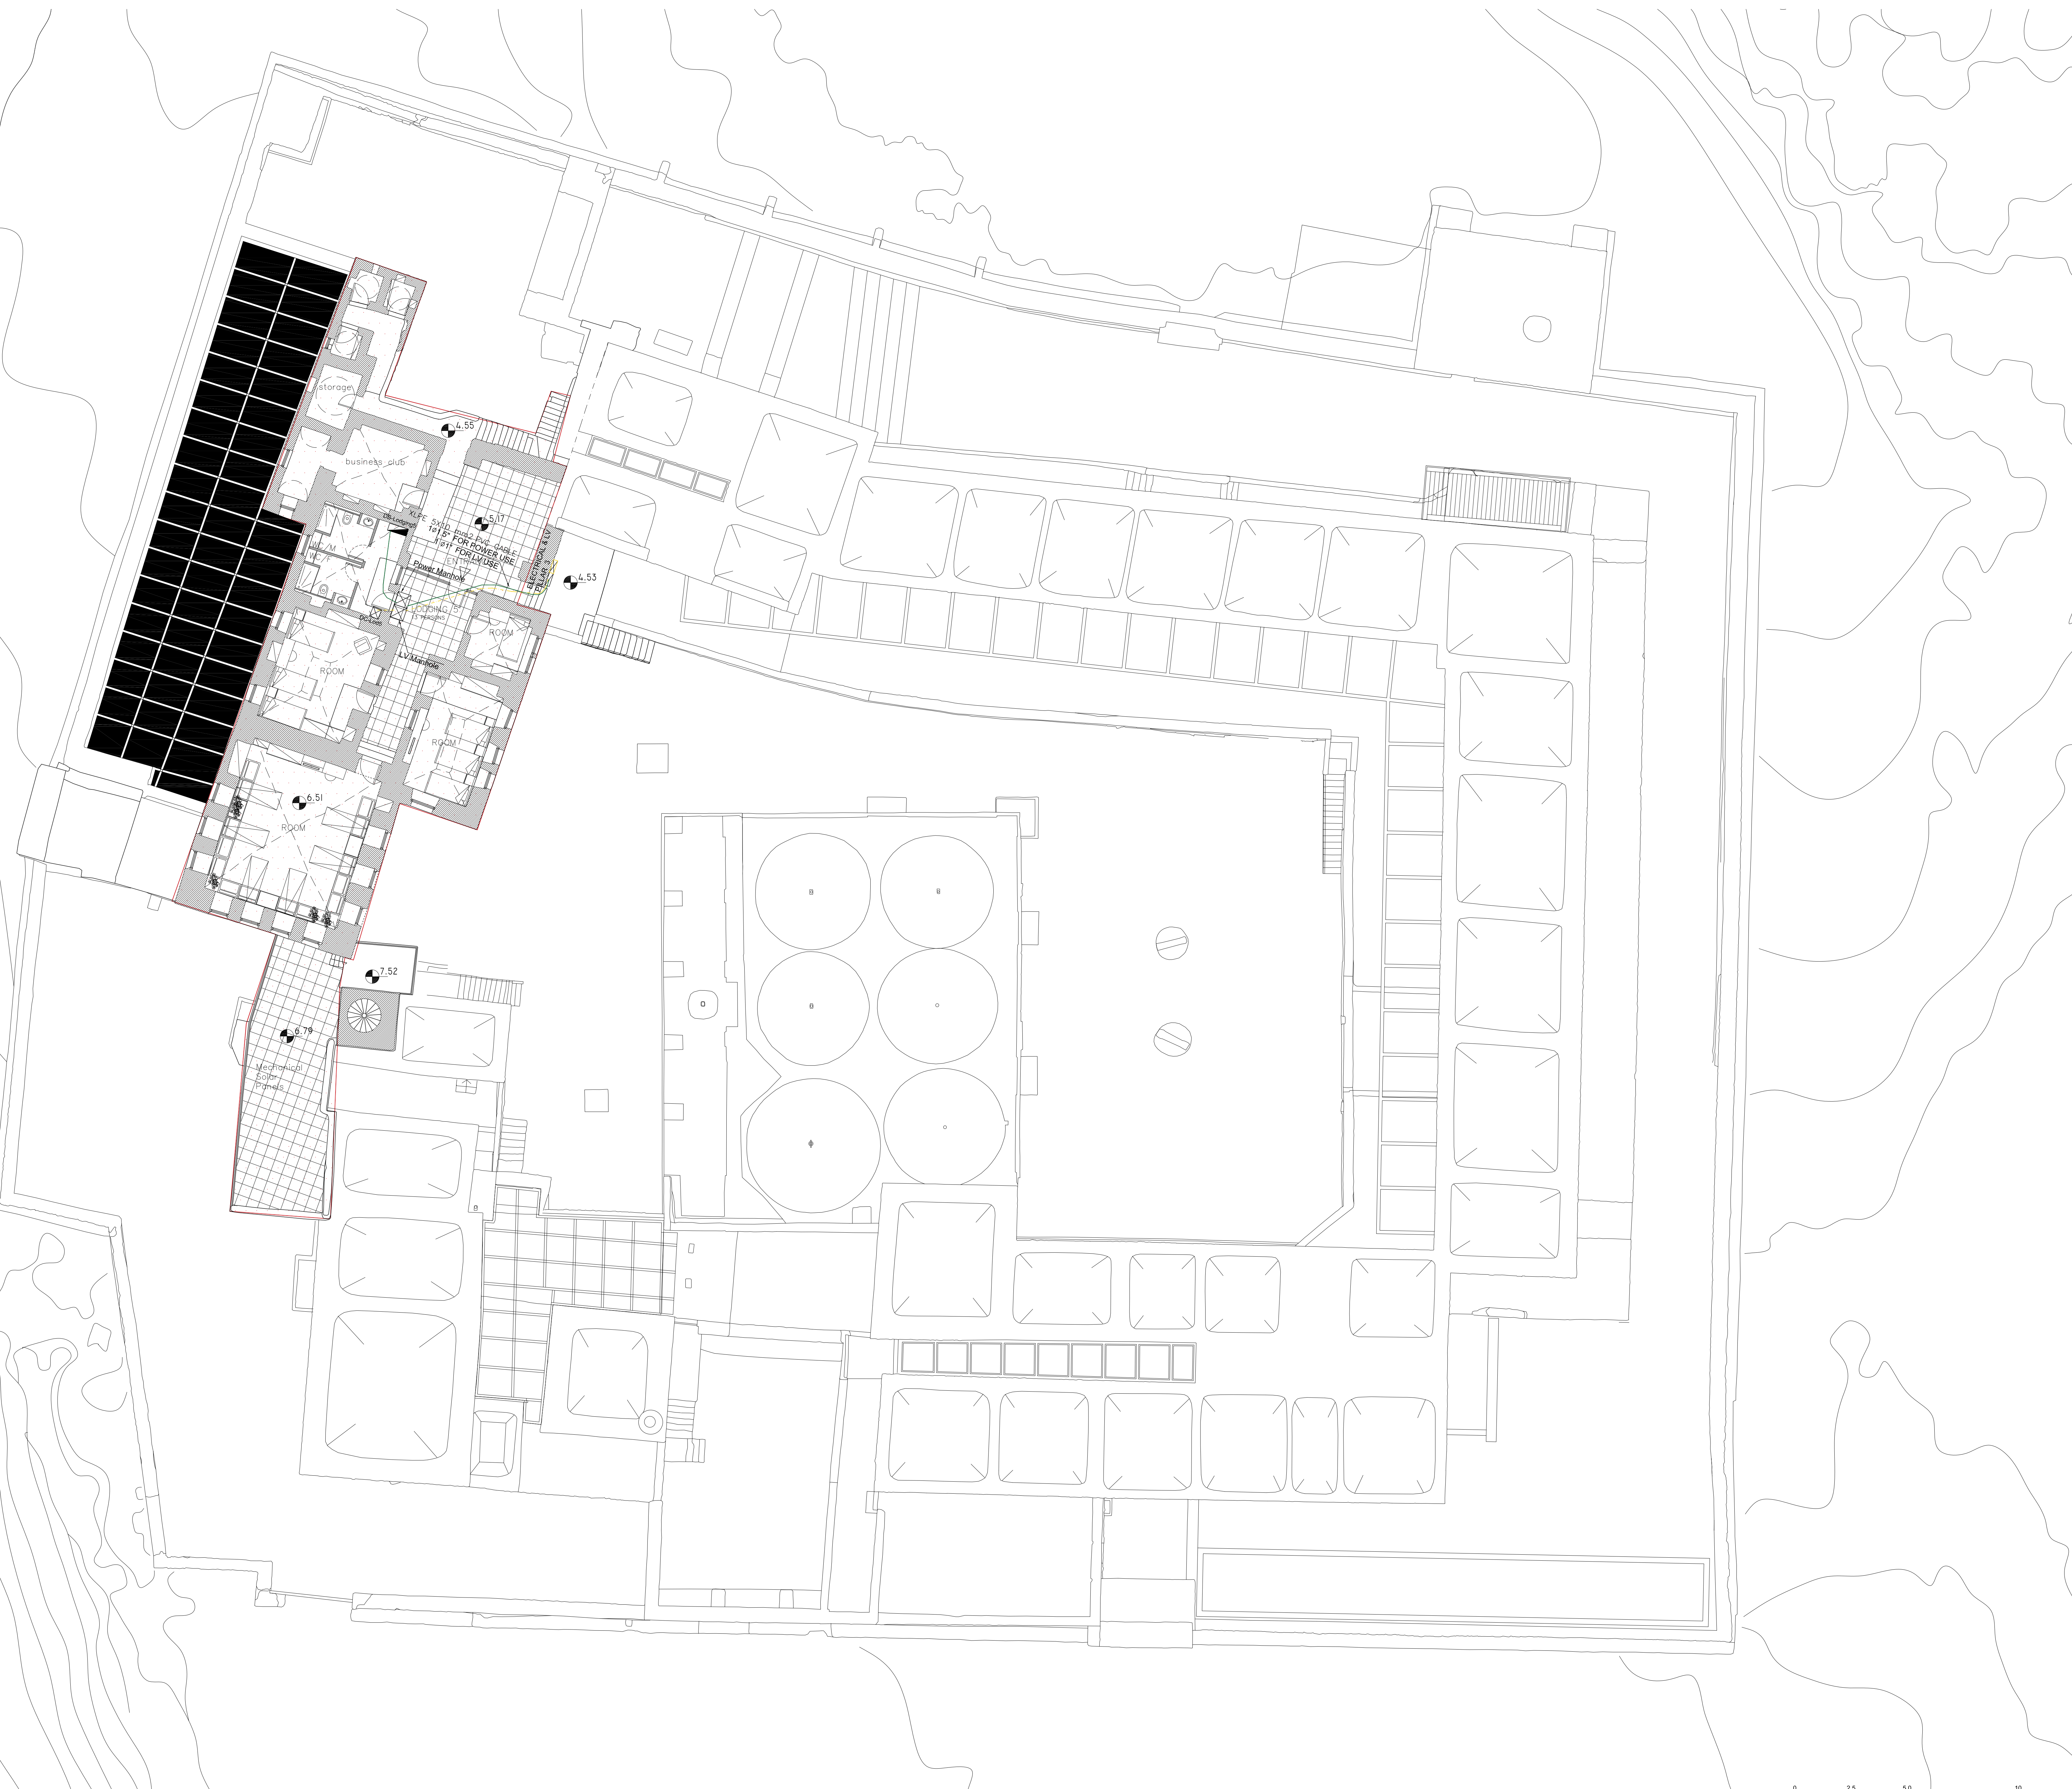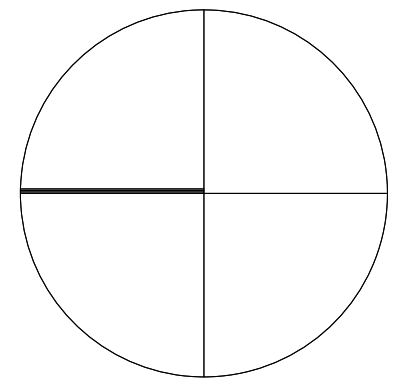

NOTES & LEGEND:

SYMBOL	DESCRIPTION
	THREE/SINGLE PHASE
	MAIN ELECTRIC BOARD LV. SIDE
	METAL ELECTRIC BOARD WITH LOW VOLTAGE SIDE
	DISTRIBUTION BOARD
	GENERATOR
	STEP RELAY
	MOTORIZED AIR CIRCUIT BREAKER WITH TRIP RATING
	CONTACTOR
	INDICATOR LAMPS WITH PUSH BUTTON
	GENERAL MULTIMETER
	AMETER/VOLTMETER
	TRANSFORMER
	THREE/SINGLE PHASE FUSE
	THREE/SINGLE PHASE EARTH LEAKAGE RELAY
	THREE PHASE KWHM
	SINGLE PHASE KWHM
	4-POLE CHANGE OVER SWITCH MANUAL OR AUTO
	CHECK BOX
	60*60CM ELECTRICAL MANHOLE
	60*60CM TELEPHONE MANHOLE

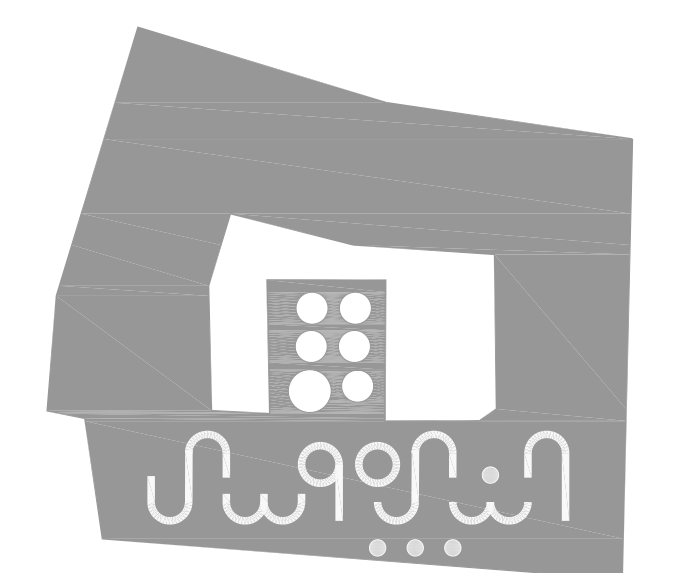

PROJECT:
Securing Professional Services for the Architectural Restoration and Rehabilitation Designs, Archaeological Documentation and Orientation Training, Including Tender Documents Preparation and Site Supervision for Conservation and Rehabilitation Works of Maqam Al-Nabi Musa in Jericho Governorate
Support to Development of Cultural Tourism



DESIGN WORKS:
-Jerusalem Design Center

ELECTRICAL WORKS:
-Eng .Midhat AlSharif

MECHANICAL WORKS:
-Elite Mechanical Consultants

SHEET NAME:
Second Floor
MAIN FEEDER LINES

SCALE: 1:100 if plotted on A0	EDITION:
☐ For Review	SHEET NO.
☐ For Approval	
☒ For Tender	
☐ For Construction	
DATE: July-2016	

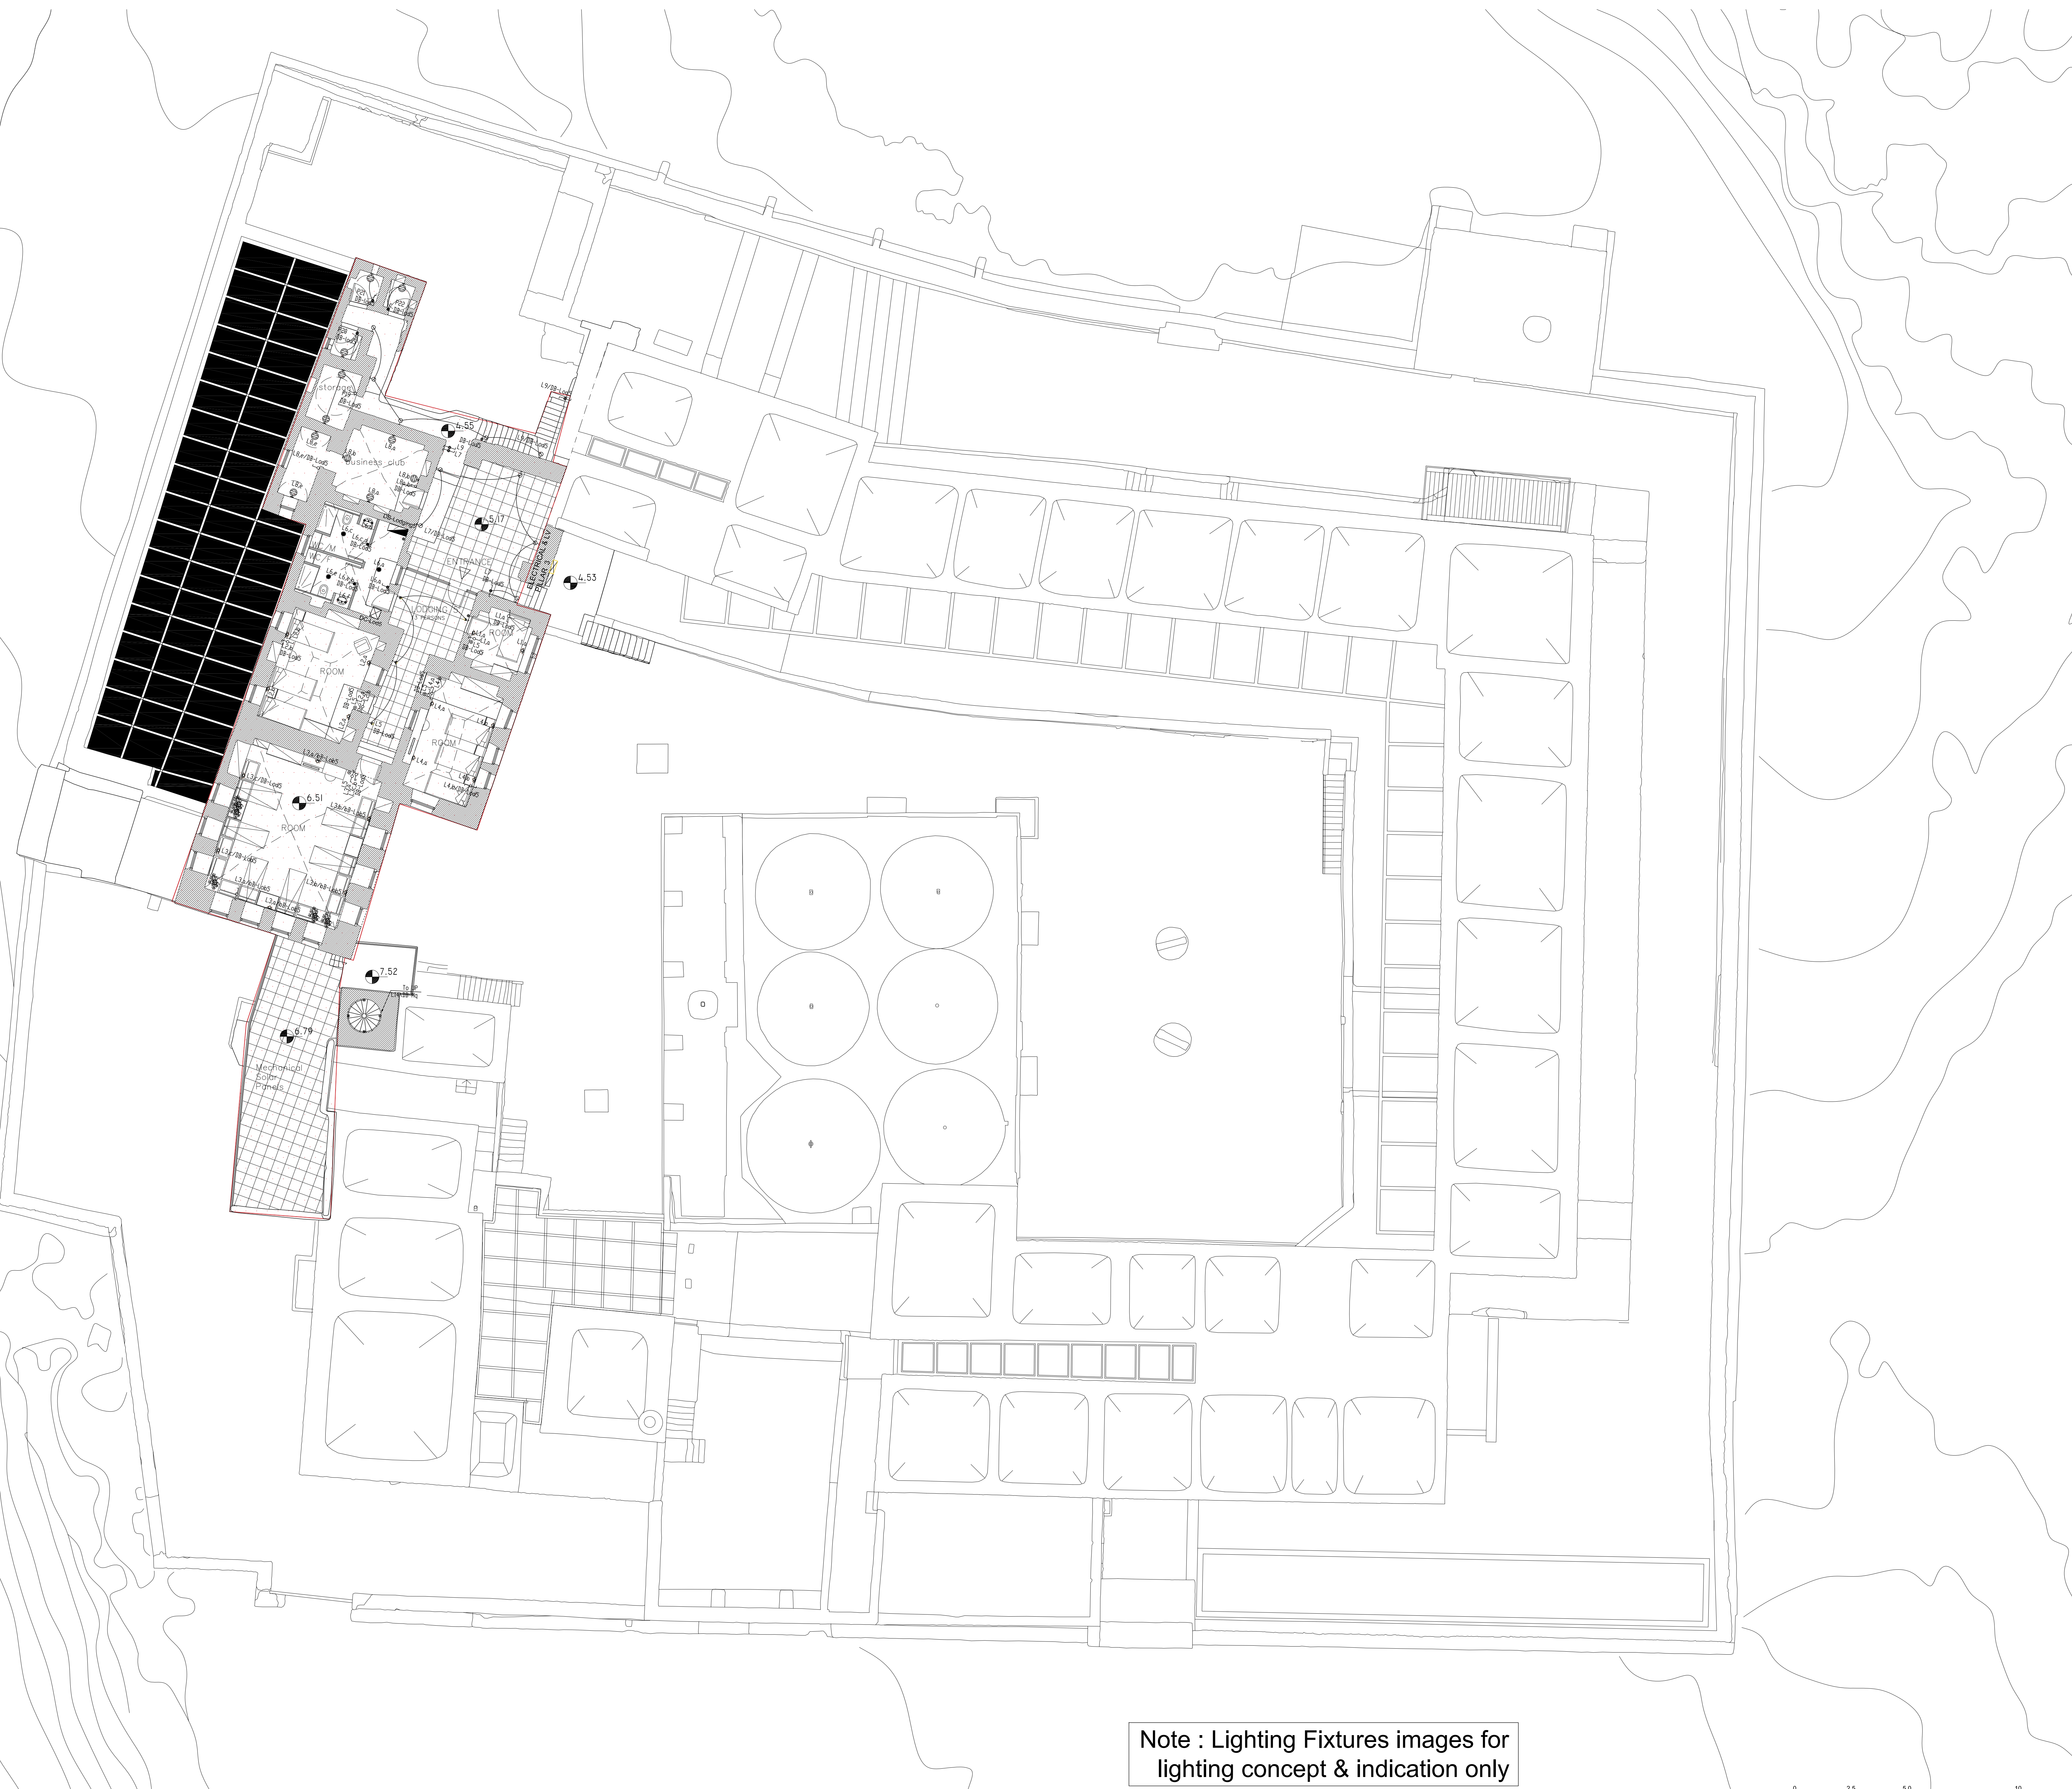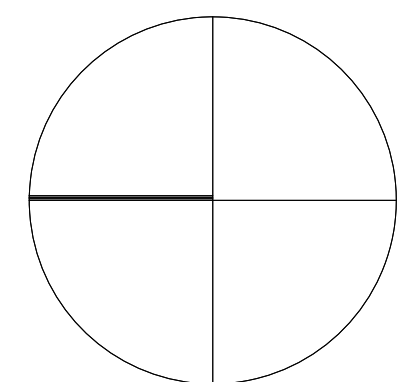


Note : Lighting Fixtures images for
lighting concept & indication only



NOTES & LEGEND:

SYMBOL	DESCRIPTION
LIGHTING FIXTURE & SWITCHES	
	Type 1 Lighting For Lodging Rooms
	Type 2 Lighting For Corridor Lodging
	Type 3 Lighting For Chandelier Mosque
	Type 4 Lighting For Chandelier For the Mosque
	Type 5 Lighting For Mosque Mosque
	Type 6 Wall Recessed led for pathway For the Mosque of the Mosque
	Type 7 Wall mounted lighting fixture up/down light
	Type 8 Lighting For Storage
	Type 9 Wall Recessed Light 3 Watt LED
	Type 10 Wall Recessed 3 Watt Led
	Type 11 LED type with red sign and arrows emergency lighting EX
	Type 12 LED FLOOR SPOT 2W IP 65
	Type 13 Lighting For Restaurant
	Type 14 Lighting For Restaurant
	Type 15 Lighting For Restaurant
	Type 16 18W LED, FALSE ceiling recessed lighting fixture
	Type 17 Recessed down light 18W LED with Polycarbonate Lens
	Type 18 2X2W 15 Ceiling Mount V.P. Fluorescent
	Type 19 Lighting For Shop
	Type 20 Lighting For Office Up/In
	Type 21 Multi Directional Spot Lighting For Exhibitions
	Type 22 directional spot Lighting
	Type 23 Lighting For Entrance
	Type 24 18 watt LED wall mount up/down, IP65 fixture
	Type 25 Lighting For Outer Wall Warm white LED 15Watt
	Type 26 Lighting For External Gate
	Type 27 Waterproof Led Strip
	Type 28 Switch LED type emergency Lighting kit 90 min. Electroluminescent or GS
	Type 29 Lighting Pole For Outside Area
	Type 30 Smart switch for 2 ways
	Type 31 Smart switch for 4 ways
	Type 32 Smart switch for 8 ways
	Type 33 PUSH BUTTON
	Type 34 SINGLE POLE ONE GANG SWITCH / W.P.
	Type 35 SINGLE POLE TWO GANG SWITCH / W.P.
	Type 36 SINGLE POLE THREE GANG SWITCH / W.P.
	Type 37 TWO WAY SWITCH / W.P.

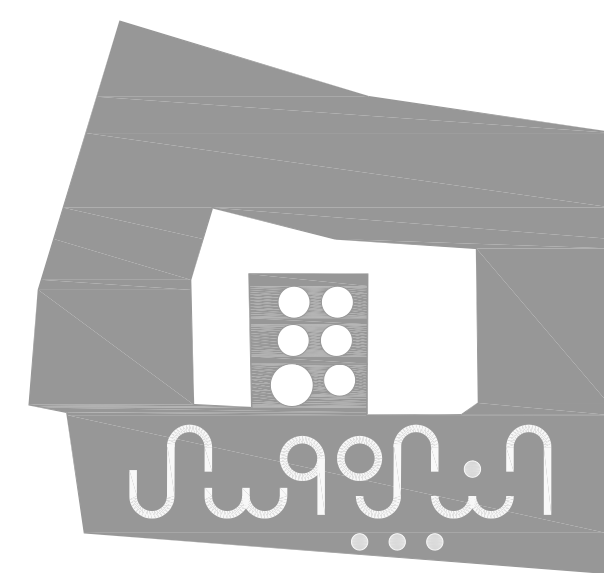

PROJECT:

Securing Professional Services for the Architectural Restoration and Rehabilitation Designs, Archaeological Documentation and Orientation Training, Including Tender Documents Preparation and Site Supervision for Conservation and Rehabilitation Works of Maqam Al-Nabi Musa in Jericho Governorate

Support to Development of Cultural Tourism

DESIGN WORKS:

-Jerusalem Design Center

ELECTRICAL WORKS:

-Eng .Midhat AlSharif

MECHANICAL WORKS:

-Elite Mechanical Consultants

SHEET NAME:

Second Floor
Lighting System

SCALE: 1:100
if plotted on A0

☐ For Review
☐ For Approval
☒ For Tender
☐ For Construction


DATE: July-2016

EDITION:

SHEET NO.

E-21



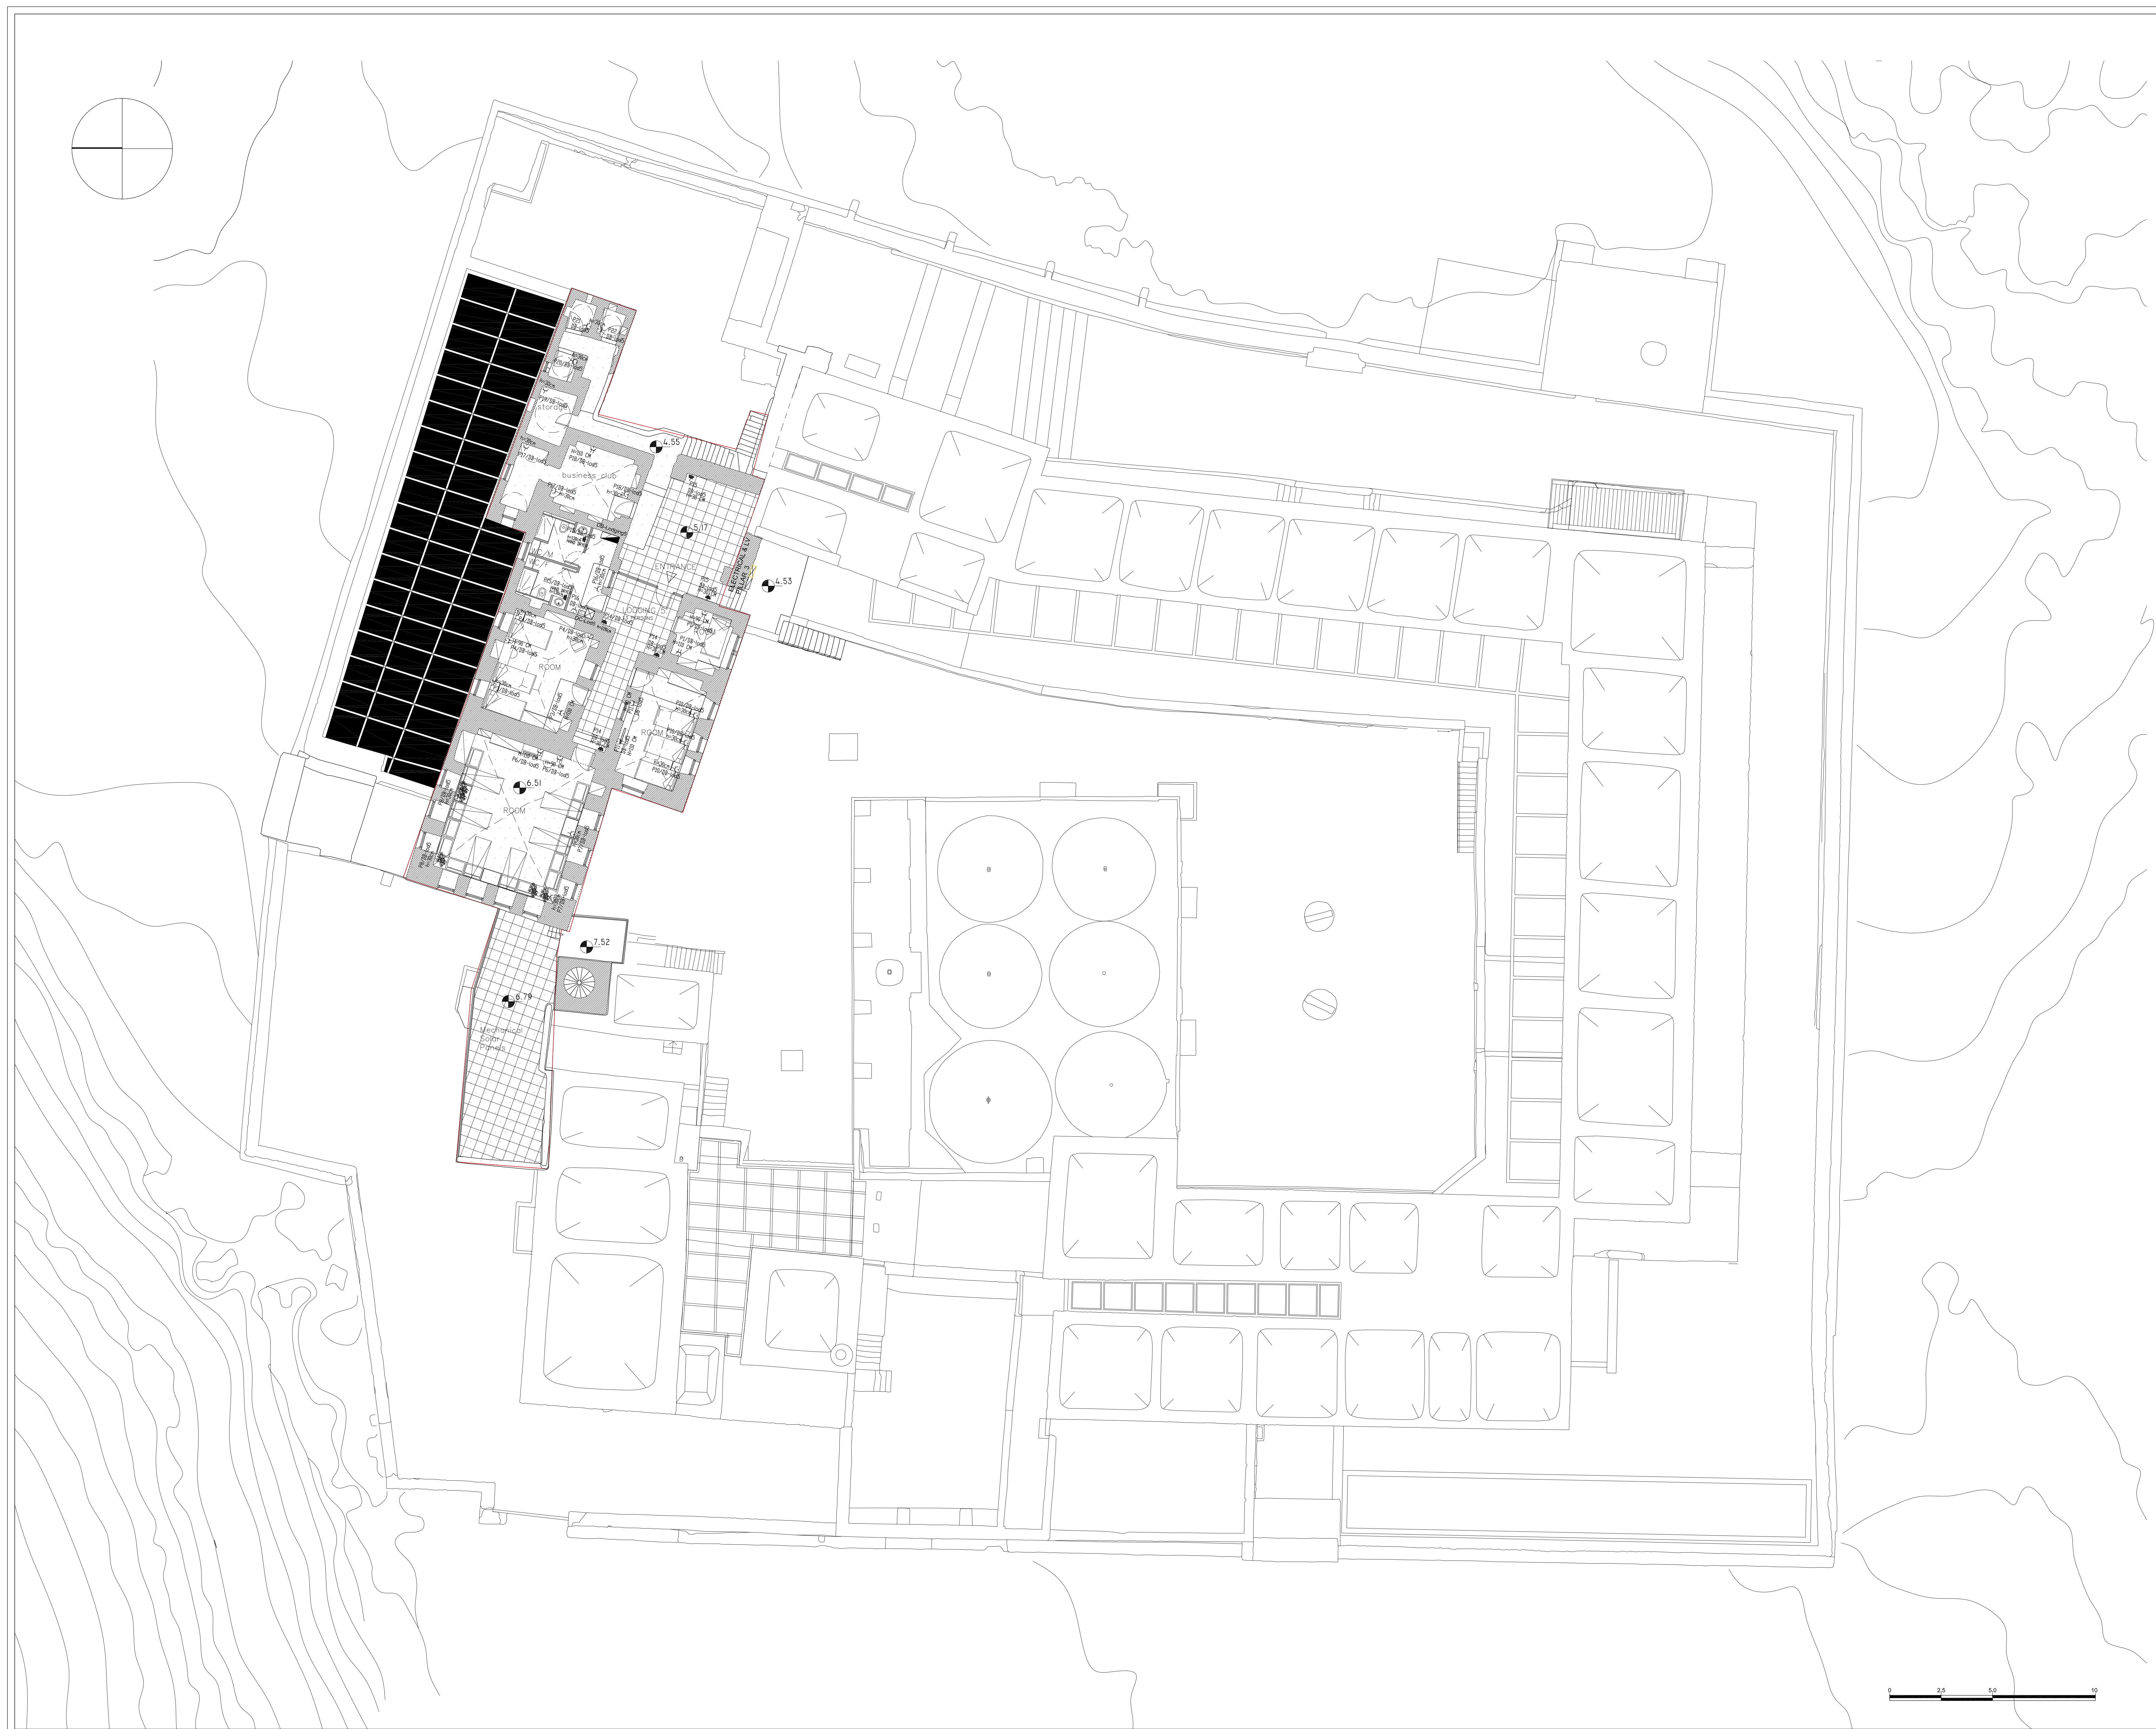

DESIGN WORKS:

 -Jerusalem Design Center


MECHANICAL WORKS:

 -Elite Mechanical Consultants

SCALE: 1:100 if plotted on A0	EDITION:
----------------------------------	----------


- DATE: July-2016



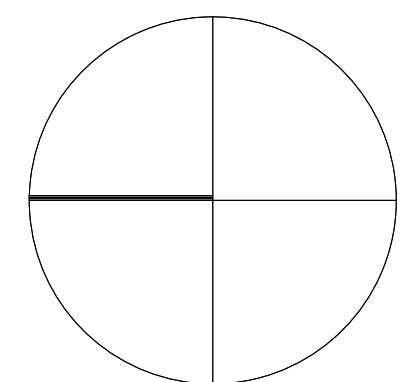

NOTES & LEGEND:

SYMBOL	DESCRIPTION
	L.V. SOCKETS
	TELEPHONE SOCKET OUTLET
	I.V. SOCKET OUTLET
	DATA SOCKET OUTLET
	LOW VOLTAGE BOX
	COMPUTER PATCH PANEL
	INTERCOM
	Wifi-Point
	Data Cabinet
	AS 25 WIRING
	RJ 45 WIRING
	VGA WIRING
	VIDEO
	PROJECTOR
	VISA
	CCTV SYSTEM
	BDRM INDOOR COLORED CAMERA
	FIXED OUTDOOR COLORED CAMERA DAY/NIGHT
	SPLIT SCREEN MONITOR
	CCTV CENTRAL MONITOR

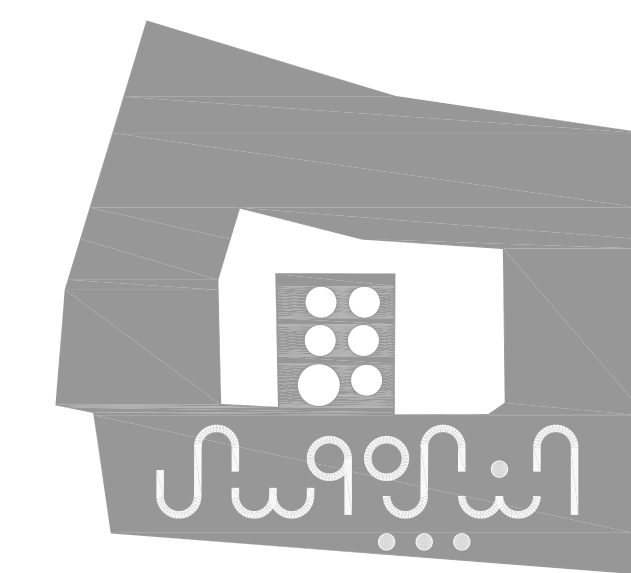

PROJECT:

Securing Professional Services for the Architectural Restoration and Rehabilitation Designs, Archaeological Documentation and Orientation Training, Including Tender Documents Preparation and Site Supervision for Conservation and Rehabilitation Works of Maqam Al-Nabi Musa in Jericho Governorate

Support to Development of Cultural Tourism

DESIGN WORKS:

-Jerusalem Design Center

ELECTRICAL WORKS:

-Eng .Midhat AlSharif

MECHANICAL WORKS:

-Elite Mechanical Consultants

SHEET NAME:

Second Floor
LV Systems

SCALE: 1:100
if plotted on A0

- ☐ For Review
- ☐ For Approval
- ☒ For Tender
- ☐ For Construction

DATE: July-2016


EDITION:

SHEET NO.

E-23




0 2.5 5.0 10

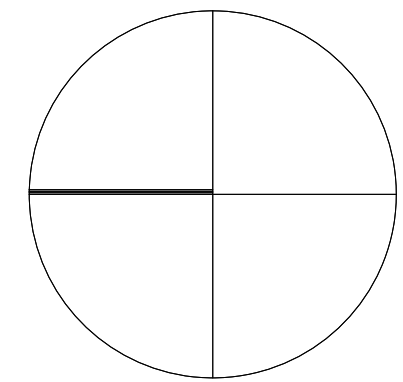

NOTES & LEGEND:

SYMBOL	DESCRIPTION	
	POWER SOCKETS	H= (cm) alt.
	16A 3 PIN SOCKET OUTLET / W.P.	180
	16A 3 PIN SOCKET OUTLET CEILING MOUNTED	180
	16A 3 PIN TRIM SOCKET OUTLET / W.P.	180
	16A 3 PIN TRIPLE SOCKET OUTLET	180
	SINGLE PHASE (2POLE) ISOLATOR, Rate As Indicated	220
	THREE PHASE (4POLE) ISOLATOR, Rate As Indicated	220
	JUNCTION BOX	160
	EMERGENCY TRIP PUSH BUTTON	220
	THERMOSTAT	160
	3 PHASE SOCKET	150
	3 PHASE SOCKET INTERLOCKED	
	W.P. 16A 3 PIN SOCKET OUTLET WITH DOUBLE POLE SWITCH WITH INDICATOR LAMP	
	W.P. 16A 3 PIN SOCKET OUTLET WITH DOUBLE POLE SWITCH WITH INDICATOR LAMP	
	W.P. 16A 3 PIN SOCKET OUTLET WITH DOUBLE POLE SWITCH WITH INDICATOR LAMP	
	Double UPS socket	

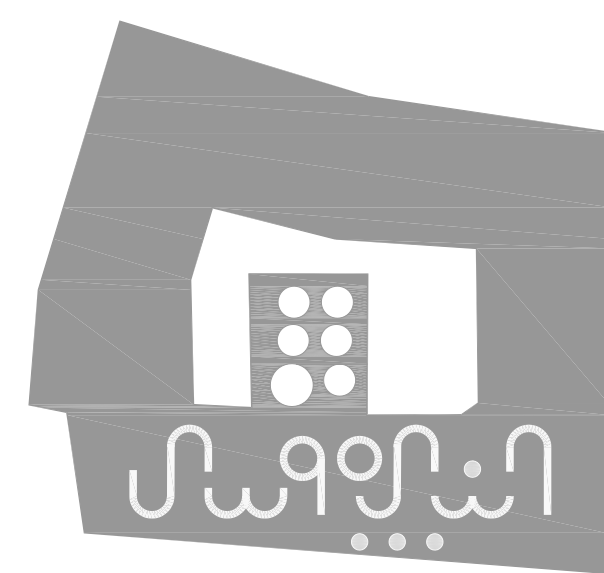

PROJECT:

Securing Professional Services for the Architectural Restoration and Rehabilitation Designs, Archaeological Documentation and Orientation Training, Including Tender Documents Preparation and Site Supervision for Conservation and Rehabilitation Works of Maqam Al-Nabi Musa in Jericho Governorate

Support to Development of Cultural Tourism

DESIGN WORKS:

-Jerusalem Design Center

ELECTRICAL WORKS:

-Eng .Midhat AlSharif

MECHANICAL WORKS:

-Elite Mechanical Consultants

SHEET NAME:

Second Floor
Electromechanical System

SCALE: 1:100
if plotted on A0

EDITION:

For Review

For Approval

☒ For Tender

For Construction



DATE: July-2016

SHEET NO.

E-25

JerusalemDesignCenter
Architects, Engineers & Consultants

Phone: 02 234 3656 | Fax: 02 234 3710 | Email: info@jdc.ps

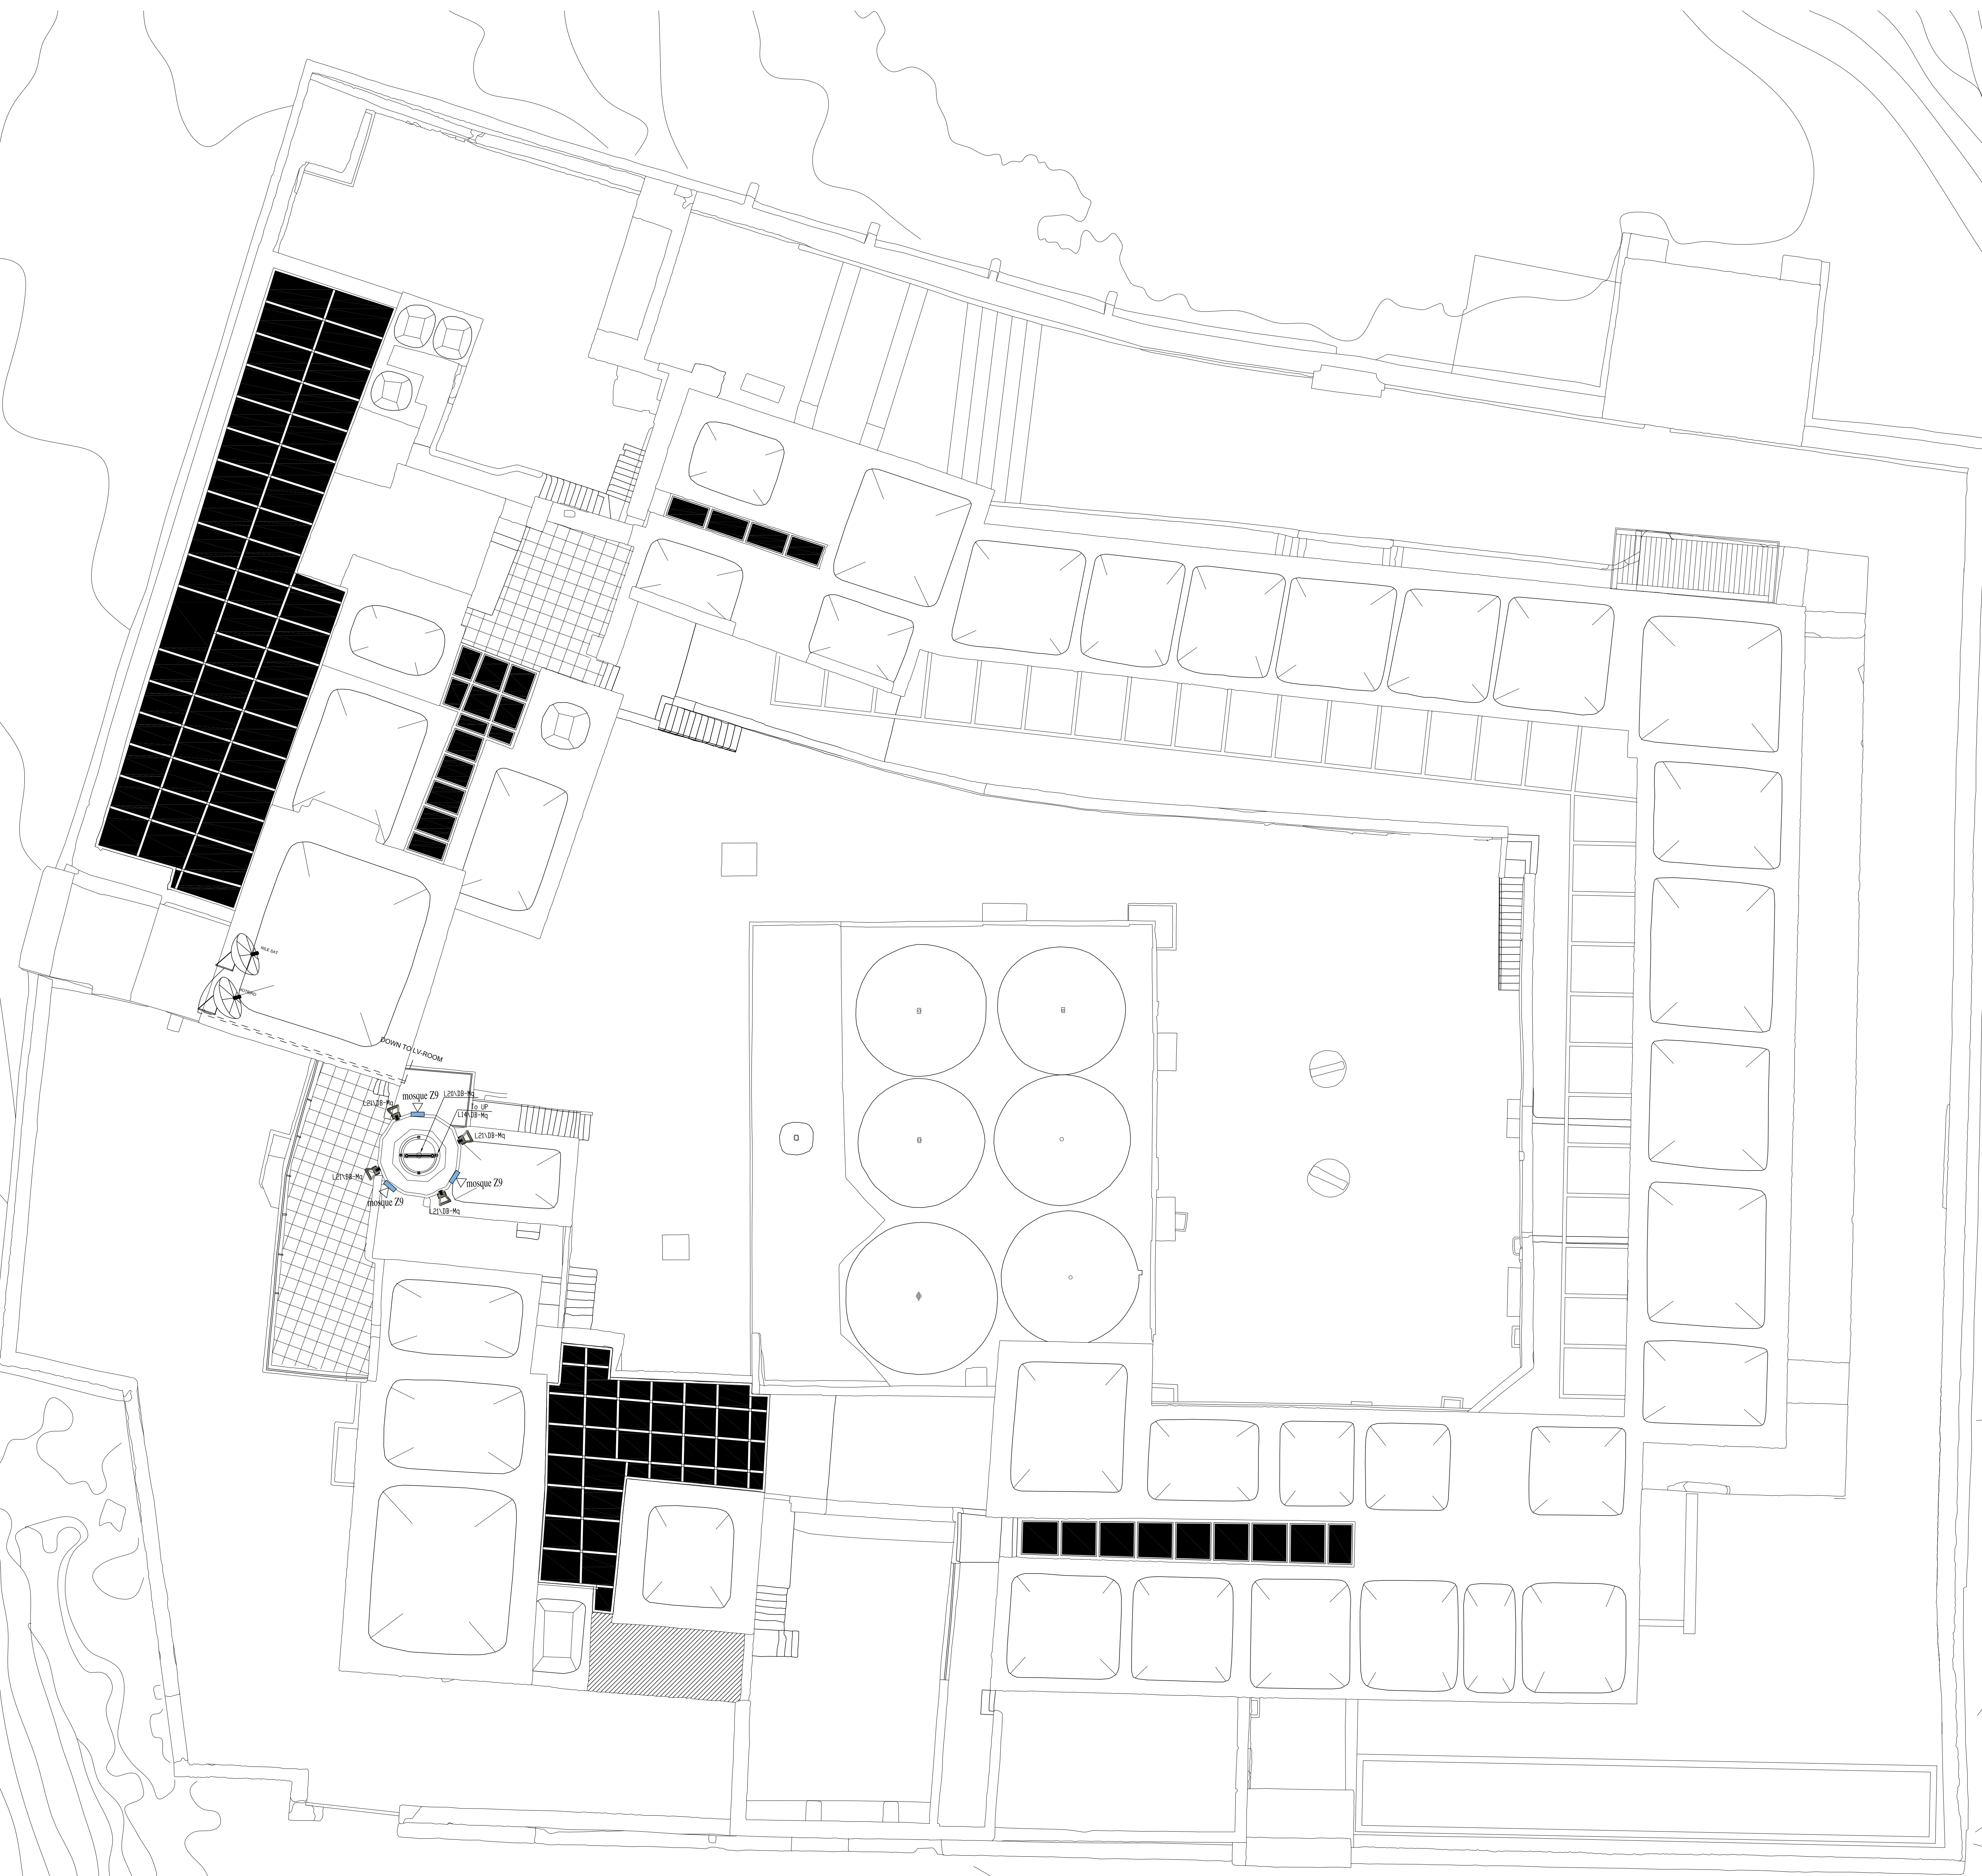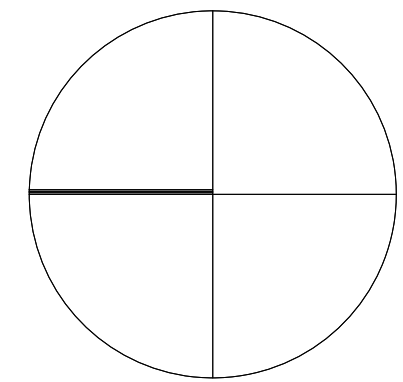

SYMBOL	DESCRIPTION	H= (cm) a.s.l.
SOUND SYSTEM		
	6WATT RECESSED LOUD SPEAKER	CEILING
	6WATT SURFACE MOUNT LOUD SPEAKER	220
	25W WALL MOUNTED ADJUSTABLE HORN	220
	END OF THE LINE	CEILING
	VOLUME CONTROL	150
	16 BUTTON CALL STATION	Table
	PUBLIC ADDRESS AND VOICE ALARM RACK	180
PENDANT SPEAKER		
	CEILING SPEAKER	
	WALL MOUNT SPEAKER	
	COLUMN SPEAKER 0.5M	
	COLUMN SPEAKER 1.0M	
	HORN SPEAKER	
	Horn speaker 2 way	
	Microphone XLR box	
	Zone No.	
	42 U rack cabinet	

NOTES & LEGEND:

SYMBOL	DESCRIPTION
LIGHTING FIXTURE & SWITCHES	
	Type 1 Lighting For Lodging Rooms
	Type 2 Lighting For Corridor Lodging
	Type 3 Lighting For Chandelier Mosque
	Type 4 Lighting For Chandelier For the Mosque
	Type 5 Lighting For Mosque
	Type 6 Wall Recessed led for pathway For the Mosque of the Mosque
	Type 7 Wall mounted lighting fixture up/down light
	Type 8 Lighting For Storage
	Type 9 Wall Recessed Light 3 Watt LED
	Type 10 Wall Recessed 3 Watt Led
	Type 11 LED type with red sign and arrows emergency lighting EX
	Type 12 LED FLOOR SPOT 3W IP 65
	Type 13 Lighting For Restaurant
	Type 14 Lighting For Restaurant
	Type 15 Lighting For Restaurant
	Type 16 18W LED, FALSE ceiling recessed lighting fixture
	Type 17 Recessed down light 30W LED with Polycarbonate Lens
	Type 18 2x20W T5 Ceiling Mount V.P. Fluorescent
	Type 19 Lighting For Shop
	Type 20 Lighting For Office Up/On
	Type 21 Multi Directional Spot Lighting For Exhibitions
	Type 22 directional spot Lighting
	Type 23 Lighting For Entrance
	Type 24 36 watt LED wall mount uppl, IP65 fixture
	Type 25 Lighting For Outer Wall Warm white LED 15Watt
	Type 26 Lighting For External Gate
	Type 27 Waterproof Led Strip
	Type 28 3 Watt LED type emergency Lighting Int. Ex. 90 mcd Electroluminescent or GS
	Type 29 Lighting Pole For Outside Area
	Smart switch for 2 ways
	Smart switch for 4 ways
	Smart switch for 8 ways
	PUSH BUTTON
	SINGLE POLE ONE GANG SWITCH / W.P.
	SINGLE POLE TWO GANG SWITCH / W.P.
	SINGLE POLE THREE GANG SWITCH / W.P.
	TWO WAY SWITCH / W.P.

PROJECT:

Securing Professional Services for the Architectural Restoration and Rehabilitation Designs, Archaeological Documentation and Orientation Training, Including Tender Documents Preparation and Site Supervision for Conservation and Rehabilitation Works of Maqam Al-Nabi Musa in Jericho Governorate

Support to Development of Cultural Tourism

DESIGN WORKS:

-Jerusalem Design Center

ELECTRICAL WORKS:

-Eng .Midhat AlSharif

MECHANICAL WORKS:

-Elite Mechanical Consultants

SHEET NAME:

Roof Floor
Electrical Systems

SCALE: 1:100
if plotted on A0

EDITION:

☐ For Review
☐ For Approval
☒ For Tender
☐ For Construction

SHEET NO.

E-26

DATE: July-2016

Note : Lighting Fixtures images for lighting concept & indication only

JerusalemDesignCenter
Architects, Engineers & Consultants

Phone: 02 234 3696 | Fax: 02 234 3710 | Email: info@jdc.gov.ps