



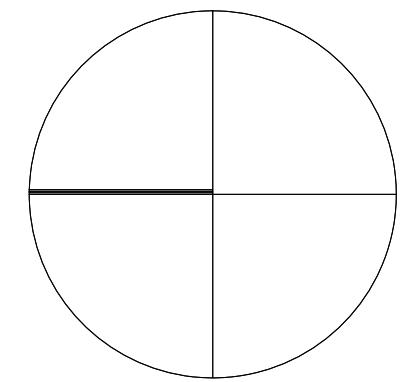

NOTES & LEGEND:

SYMBOL	DESCRIPTION	
POWER SOCKETS		H= (cm) alt.
	16A 3 PIN SOCKET OUTLET / W.P.	180
	16A 3 PIN SOCKET OUTLET CEILING MOUNTED	180
	16A 3 PIN TRIM SOCKET OUTLET / W.P.	180
	16A 3 PIN TRIPLE SOCKET OUTLET	180
	SINGLE PHASE (2POLE) ISOLATOR, Rate As Indicated	220
	THREE PHASE (4POLE) ISOLATOR, Rate As Indicated	220
	JUNCTION BOX	160
	EMERGENCY TRIP PUSH BUTTON	220
	THERMOSTAT	150
	3 PHASE SOCKET	
	3 PHASE SOCKET INTERLOCKED	
	W.P. 16A 3 PIN SOCKET OUTLET WITH DOUBLE POLE SWITCH WITH INDICATOR LAMP	
	W.P. 16A 3 PIN SOCKET OUTLET WITH DOUBLE POLE SWITCH WITH INDICATOR LAMP	
	Double UPS socket	

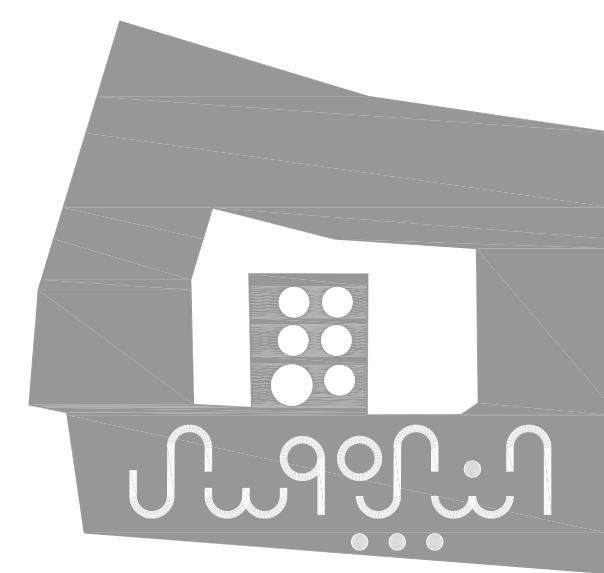

PROJECT:

Securing Professional Services for the Architectural Restoration and Rehabilitation Designs, Archaeological Documentation and Orientation Training, Including Tender Documents Preparation and Site Supervision for Conservation and Rehabilitation Works of Maqam Al-Nabi Musa in Jericho Governorate

Support to Development of Cultural Tourism

DESIGN WORKS:

-Jerusalem Design Center

ELECTRICAL WORKS:

-Eng .Midhat AlSharif

MECHANICAL WORKS:

-Elite Mechanical Consultants

SHEET NAME:

Second Floor
Electromechanical System

SCALE: 1:100
if plotted on A0

EDITION:

☐ For Review

☐ For Approval

☒ For Tender

☐ For Construction

DATE: July-2016



SHEET NO.

E-25

JerusalemDesignCenter

Architects, Engineers & Consultants


Phone: 02 234 3656 | Fax: 02 234 3710 | Email: info@jdc.gov.ps

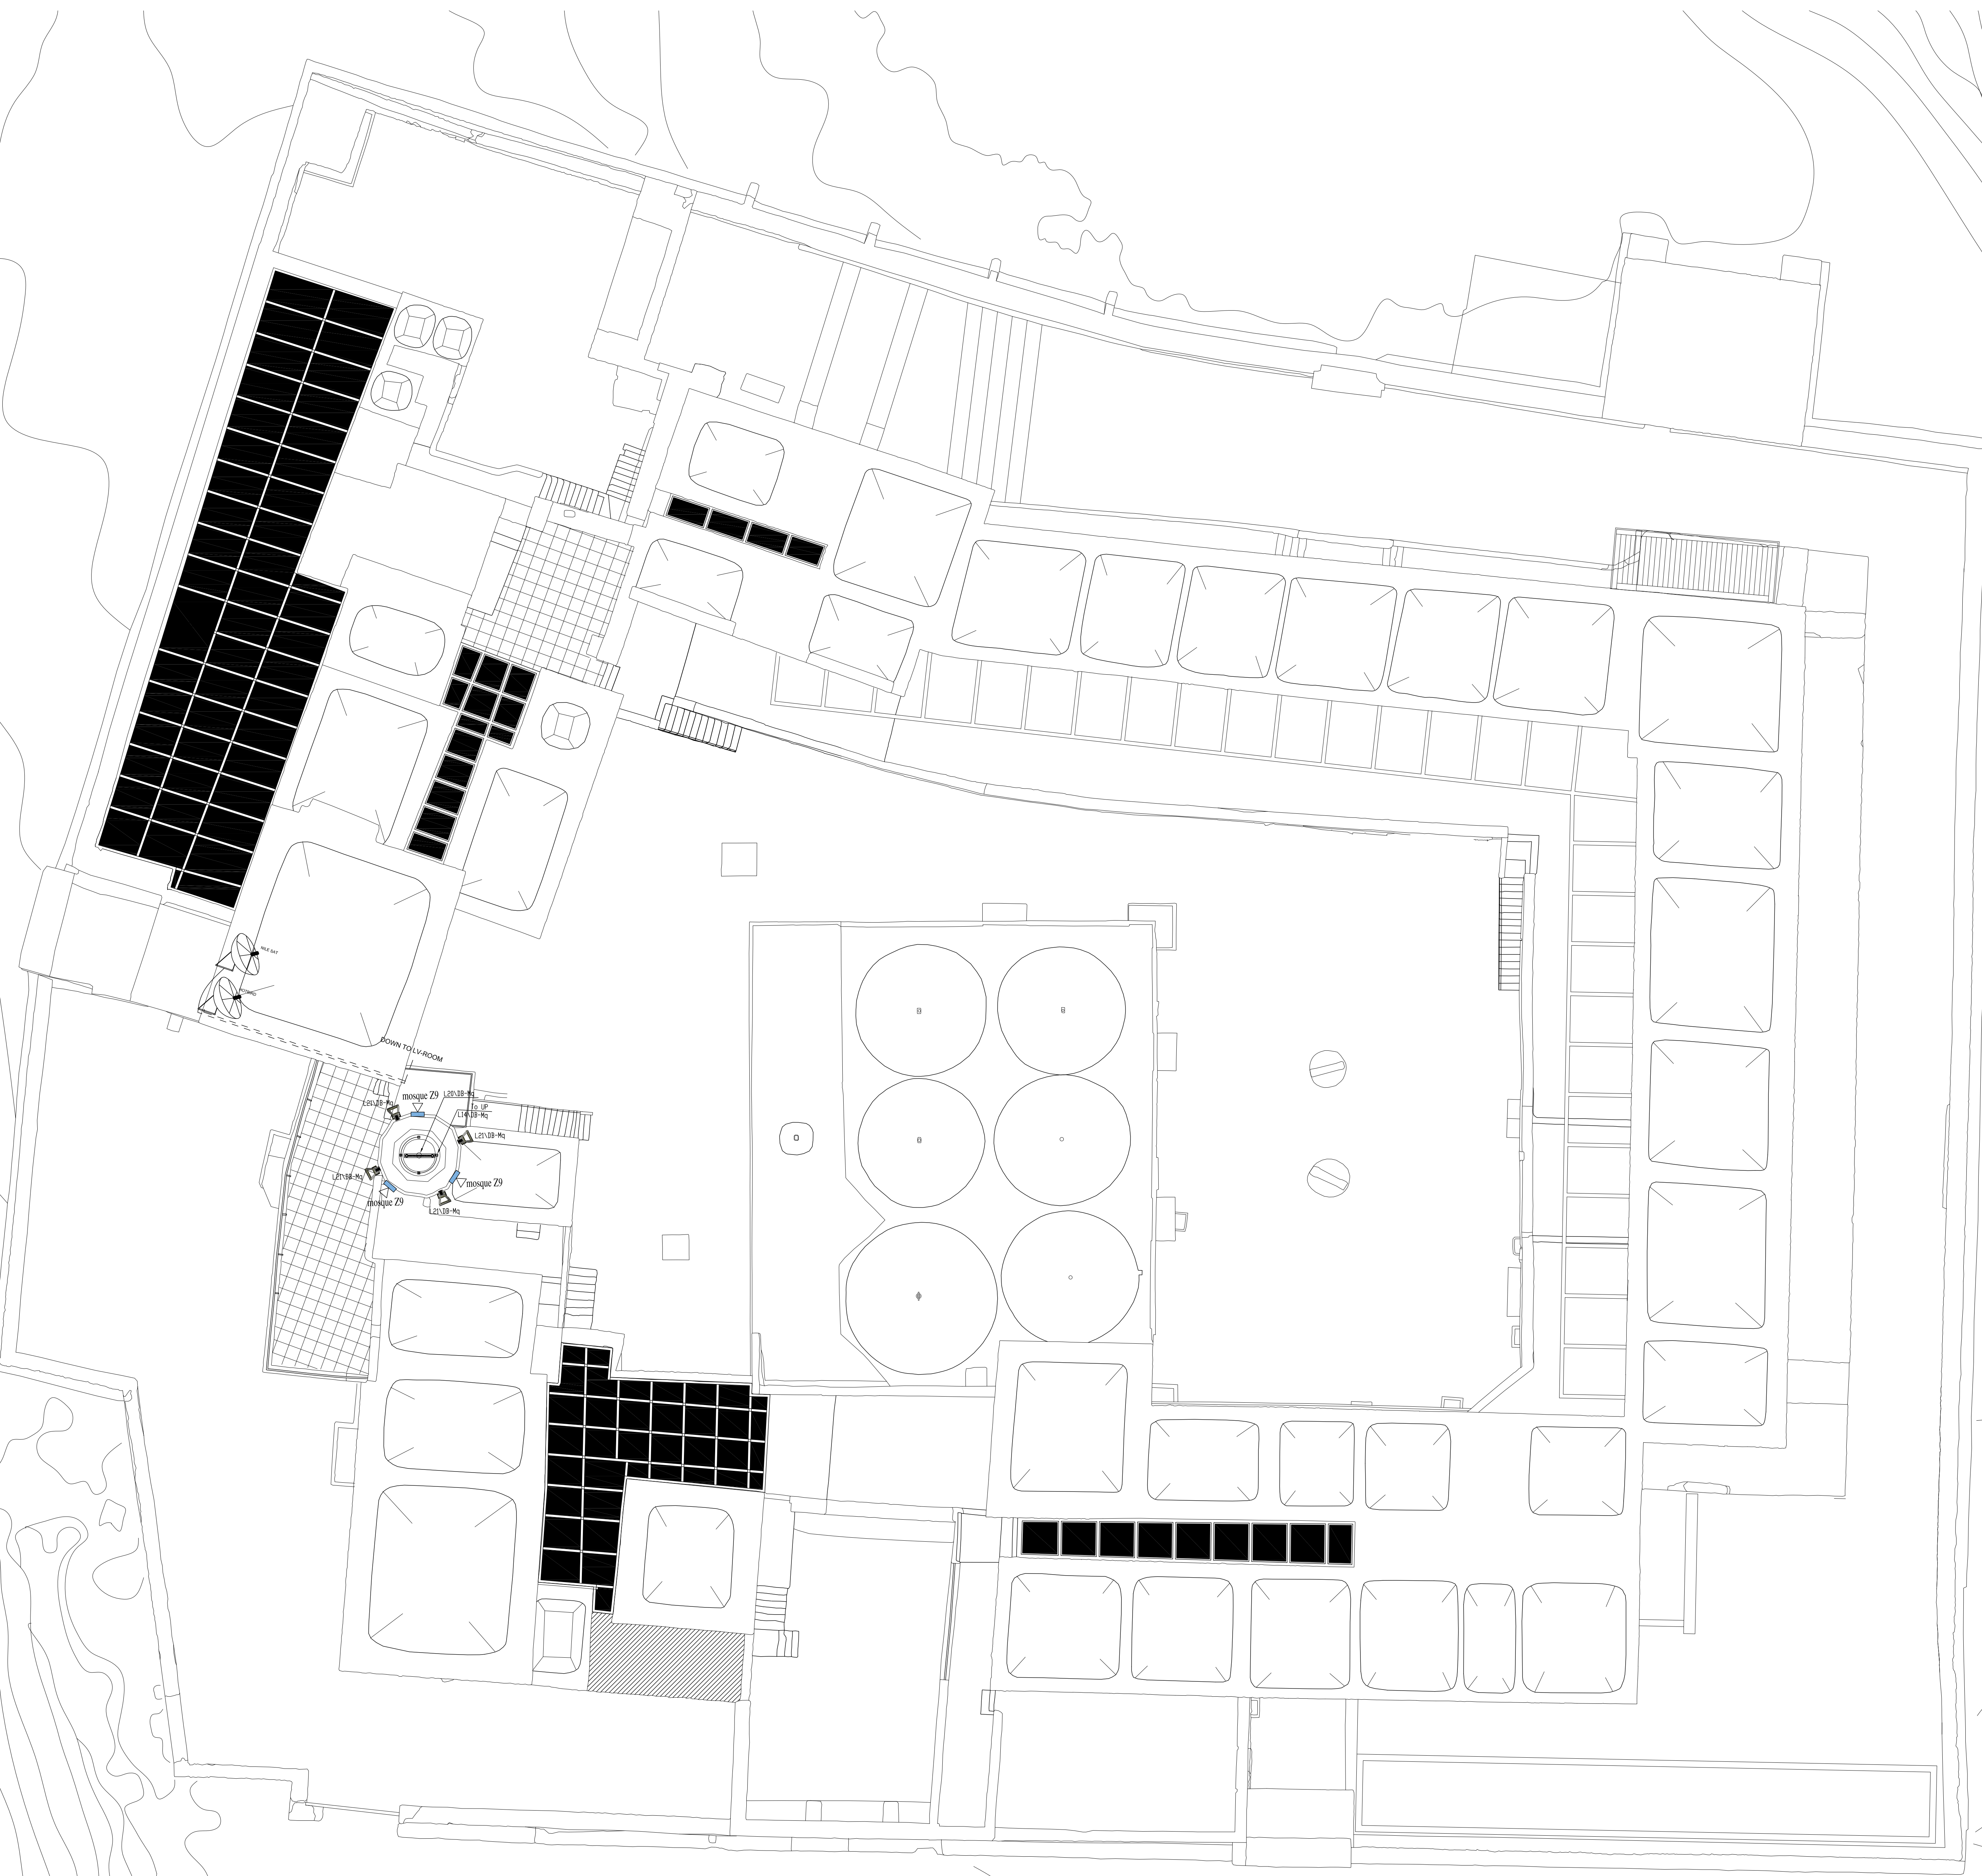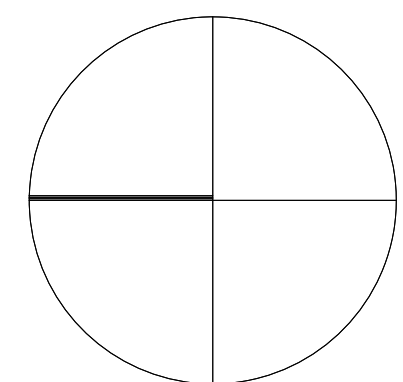

SYMBOL	DESCRIPTION	H= (cm) a.s.l.
SOUND SYSTEM		
	6WATT RECESSED LOUD SPEAKER	CEILING
	6WATT SURFACE MOUNT LOUD SPEAKER	220
	25W WALL MOUNTED ADJUSTABLE HORN	220
	END OF THE LINE	CEILING
	VOLUME CONTROL	150
	16 BUTTON CALL STATION	Table
	PUBLIC ADDRESS AND VOICE ALARM RACK	180
PENDANT SPEAKER		
	CEILING SPEAKER	
	WALL MOUNT SPEAKER	
	COLUMN SPEAKER 0.5M	
	COLUMN SPEAKER 1.0M	
	HORN SPEAKER	
	Horn speaker 2 way	
	Microphone XLR box	
	Zone No.	
	42 U rack cabinet	

NOTES & LEGEND:

SYMBOL	DESCRIPTION
LIGHTING FIXTURE & SWITCHES	
	Type 1 Lighting For Lodging Rooms
	Type 2 Lighting For Corridor Lodging
	Type 3 Lighting For Chandelier Mosque
	Type 4 Lighting For Chandelier For the Mosque
	Type 5 Lighting For Mosque
	Type 6 Wall Recessed led for pathway For the Mosque of the Mosque
	Type 7 Wall mounted lighting fixture up/down light
	Type 8 Lighting For Storage
	Type 9 Wall Recessed Light 3 Watt LED
	Type 10 Wall Recessed 3 Watt Led
	Type 11 LED type with red sign and arrows emergency lighting EX
	Type 12 LED FLOOR SPOT 3W IP 65
	Type 13 Lighting For Restaurant
	Type 14 Lighting For Restaurant
	Type 15 Lighting For Restaurant
	Type 16 18W LED FALSE ceiling recessed lighting fixture
	Type 17 Recessed down light 30W LED with Polycarbonate Lens
	Type 18 2X20W T5 Ceiling Mount V.P. Fluorescent
	Type 19 Lighting For Shop
	Type 20 Lighting For Office Up/On
	Type 21 Multi Directional Spot Lighting For Exhibitions
	Type 22 directional spot Lighting
	Type 23 Lighting For Entrance
	Type 24 18 watt LED wall mount uppl. IP65 fixture
	Type 25 Lighting For Outer Wall Warm white LED 15Watt
	Type 26 Lighting For External Gate
	Type 27 Waterproof Led Strip
	Type 28 3Watt LED type emergency Lighting Int. 90 mcd Electrolum on GS
	Type 29 Lighting Pole For Outside Area
	Smart switch for 2 ways
	Smart switch for 4 ways
	Smart switch for 8 ways
	PUSH BUTTON
	SINGLE POLE ONE GANG SWITCH / W.P.
	SINGLE POLE TWO GANG SWITCH / W.P.
	SINGLE POLE THREE GANG SWITCH / W.P.
	TWO WAY SWITCH / W.P.

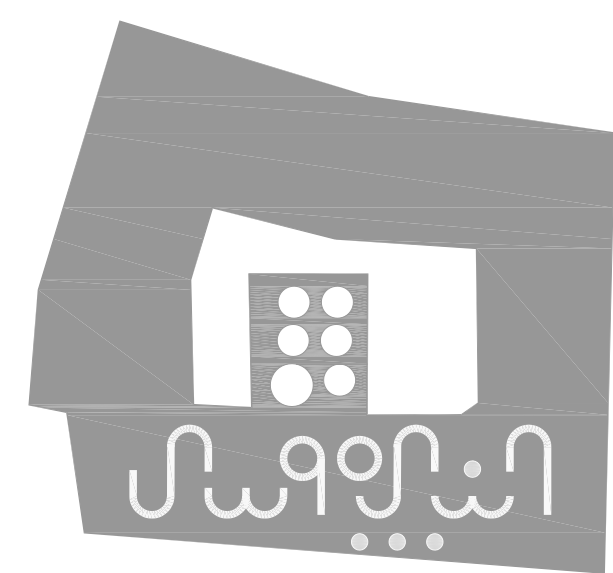

PROJECT:

Securing Professional Services for the Architectural Restoration and Rehabilitation Designs, Archaeological Documentation and Orientation Training, Including Tender Documents Preparation and Site Supervision for Conservation and Rehabilitation Works of Maqam Al-Nabi Musa in Jericho Governorate

Support to Development of Cultural Tourism

DESIGN WORKS:

-Jerusalem Design Center

ELECTRICAL WORKS:

-Eng .Midhat AlSharif

MECHANICAL WORKS:

-Elite Mechanical Consultants

SHEET NAME:

Roof Floor
Electrical Systems

SCALE: 1:100

if plotted on A0

For Review

For Approval

For Tender

For Construction

DATE: July-2016

EDITION:

 




SHEET NO.

E-26




Note : Lighting Fixtures images for lighting concept & indication only

0 2.5 5.0 10

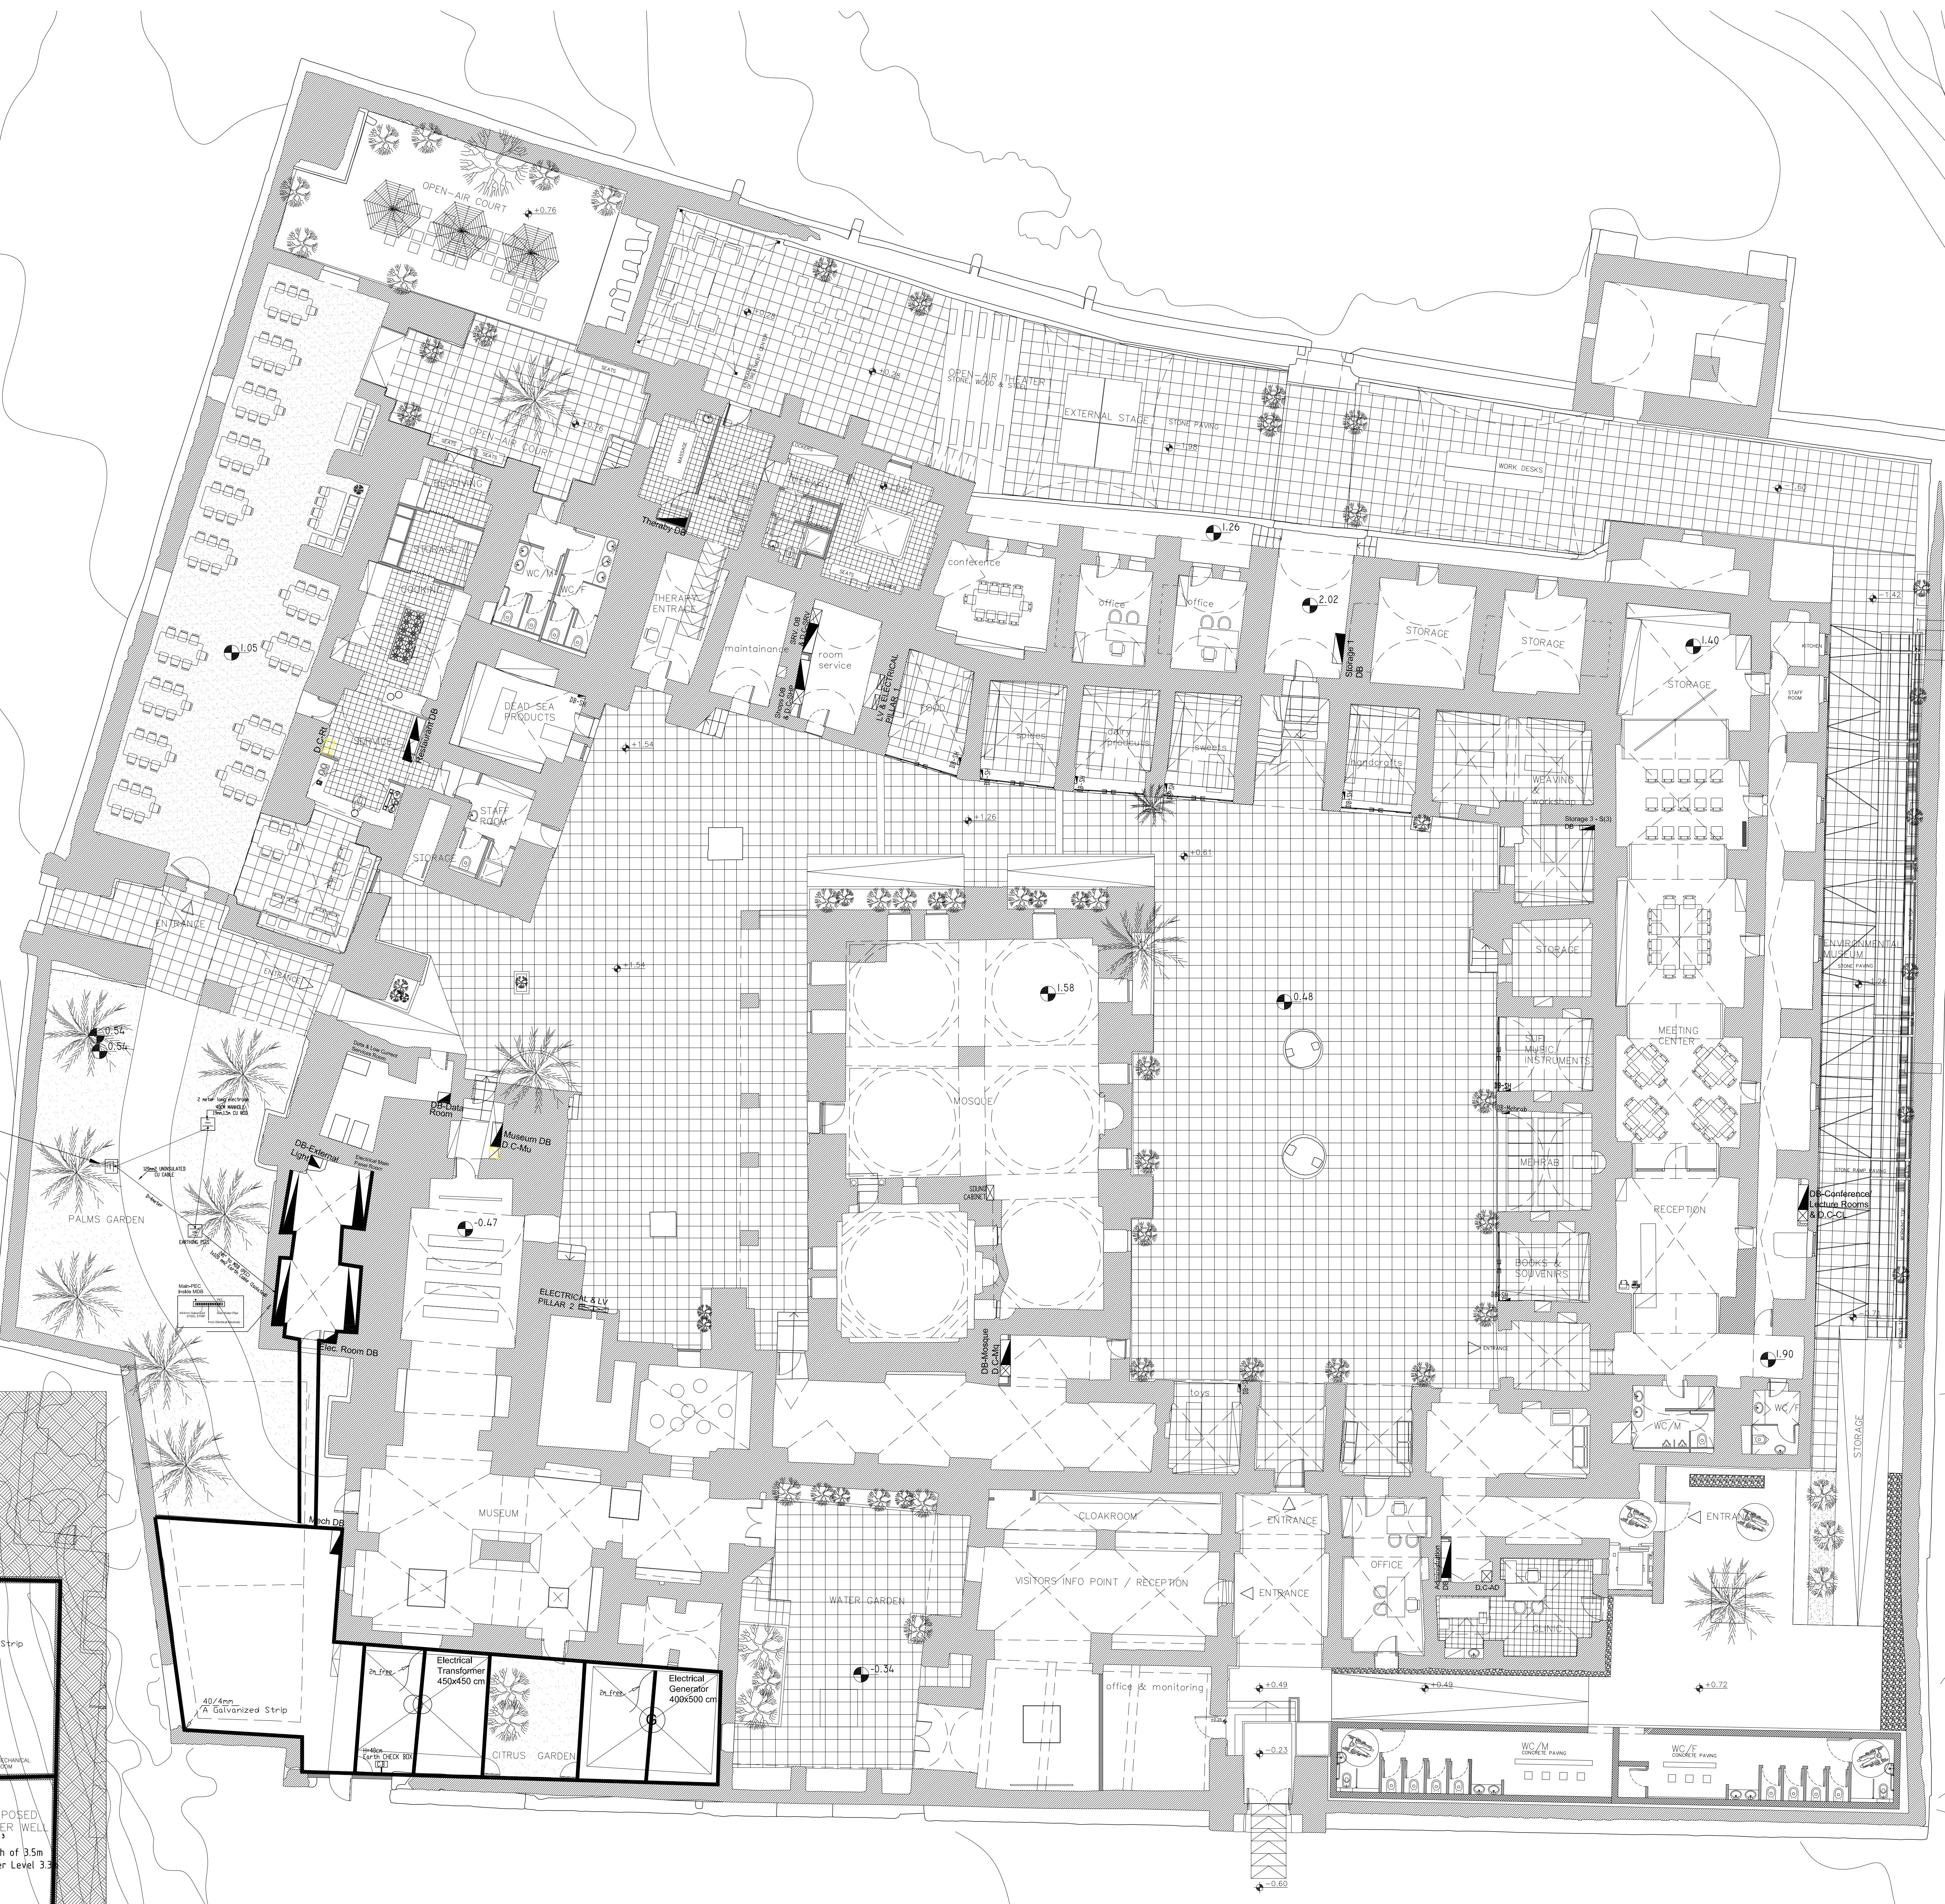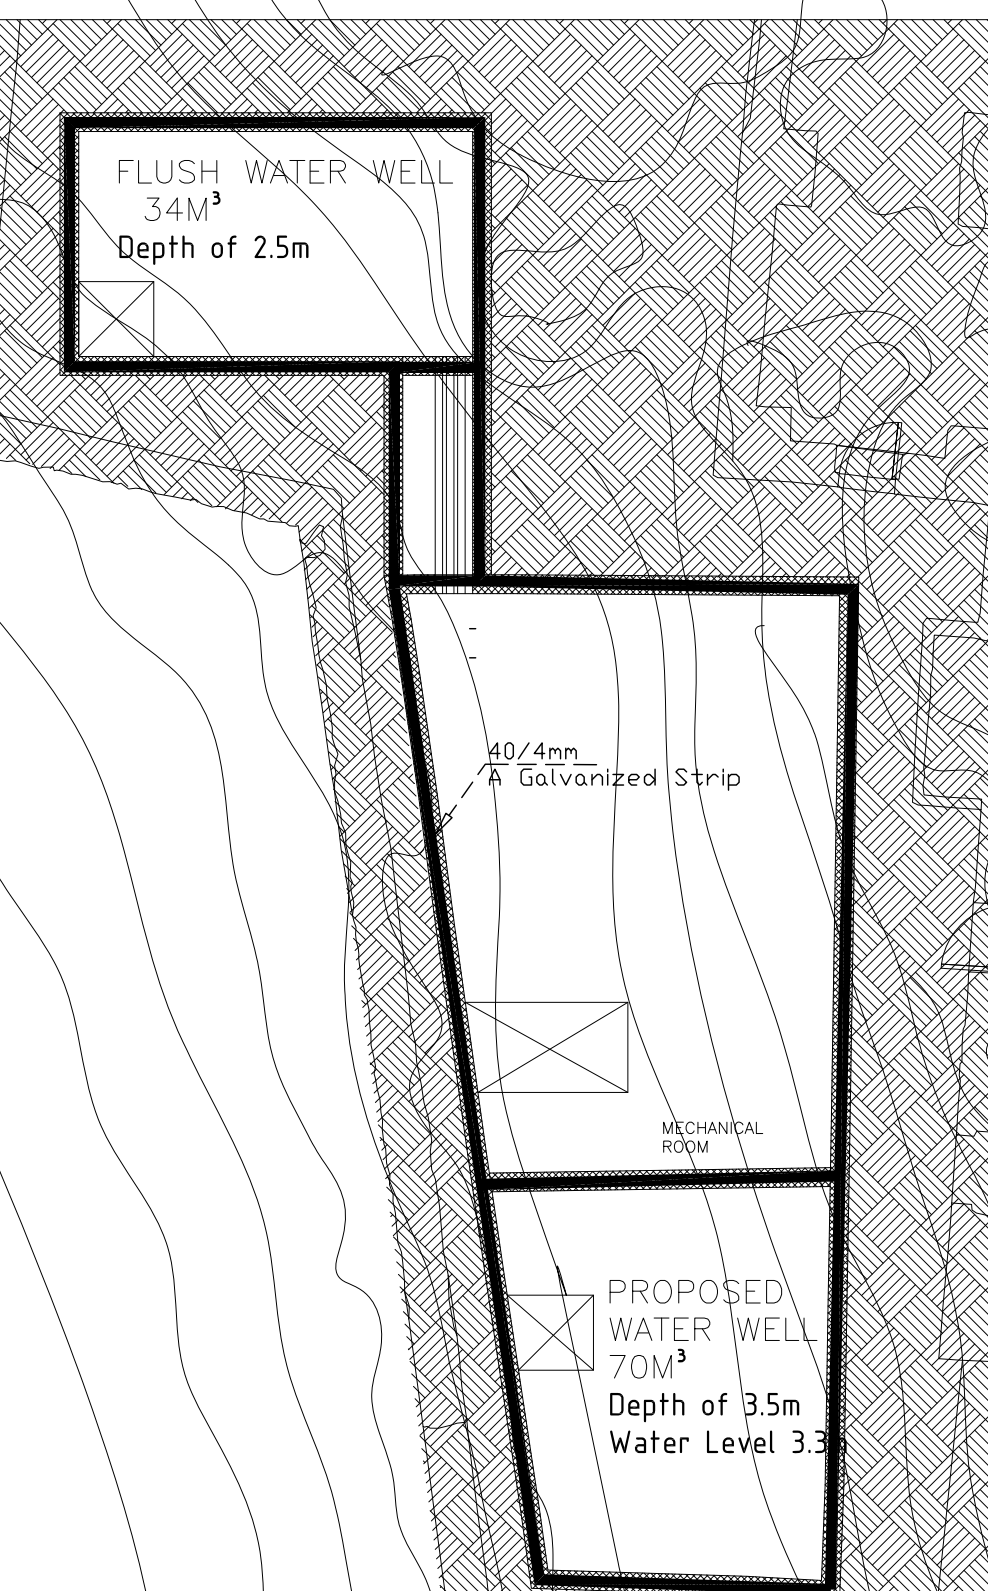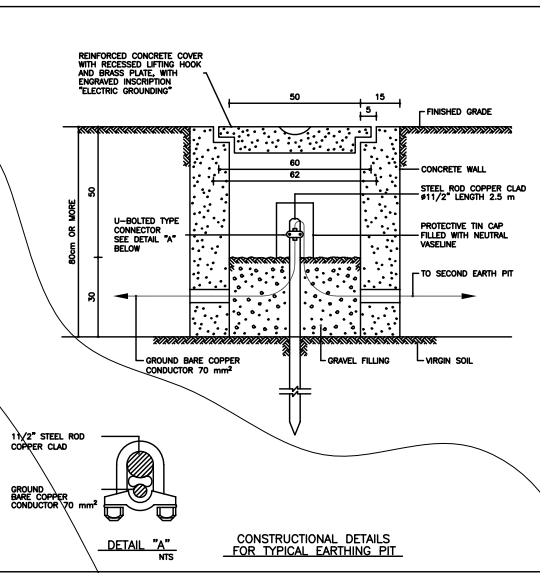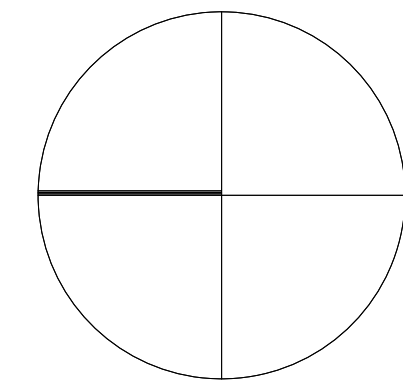

NOTES & LEGEND:	
SYMBOL	DESCRIPTION
LIGHTING FIXTURE & SWITCHES	
	Type 1 Lighting For Lodging Rooms
	Type 2 Lighting For Corridor Lodging
	Type 3 Lighting For Chandelier Mosque
	Type 4 Lighting For Chandelier For the Mosque
	Type 5 Lighting For Mosque
	Type 6 Wall Recessed led for pathway For the Mosque of the Mosque
	Type 7 Wall mounted lighting fixture up/down light
	Type 8 Lighting For Storage
	Type 9 Wall Recessed Light 3 Watt LED
	Type 10 Wall Recessed 3 Watt Led
	Type 11 LED type with red sign and arrows emergency lighting EX
	Type 12 LED FLOOR SPOT 2W IP 65
	Type 13 Lighting For Restaurant
	Type 14 Lighting For Restaurant
	Type 15 Lighting For Restaurant
	Type 16 RW LED, FALSE ceiling recessed lighting fixture
	Type 17 Recessed down light 18W LED with Polycarbonate Lens
	Type 18 2X2W 15 Ceiling Mount V.P. Fluorescent
	Type 19 Lighting For Shop
	Type 20 Lighting For Office Up/In
	Type 21 Multi Directional Spot Lighting For Exhibitions
	Type 22 directional spot Lighting
	Type 23 Lighting For Entrance
	Type 24 18 watt LED wall mount up/down light
	Type 25 Lighting For Outer Wall Warm white LED 15Watt
	Type 26 Lighting For External Gate
	Type 27 Waterproof Led Strip
	Type 28 Switch LED type emergency lighting kit 1x 90 watt Electrolux or GS
	Type 29 Lighting Plan for Outside Area
	Type 30 Smart switch for 2 ways
	Type 31 Smart switch for 4 ways
	Type 32 Smart switch for 8 ways
	Type 33 PUSH BUTTON
	Type 34 SINGLE POLE ONE GANG SWITCH / W.P.
	Type 35 SINGLE POLE TWO GANG SWITCH / W.P.
	Type 36 SINGLE POLE THREE GANG SWITCH / W.P.
	Type 37 TWO WAY SWITCH / W.P.

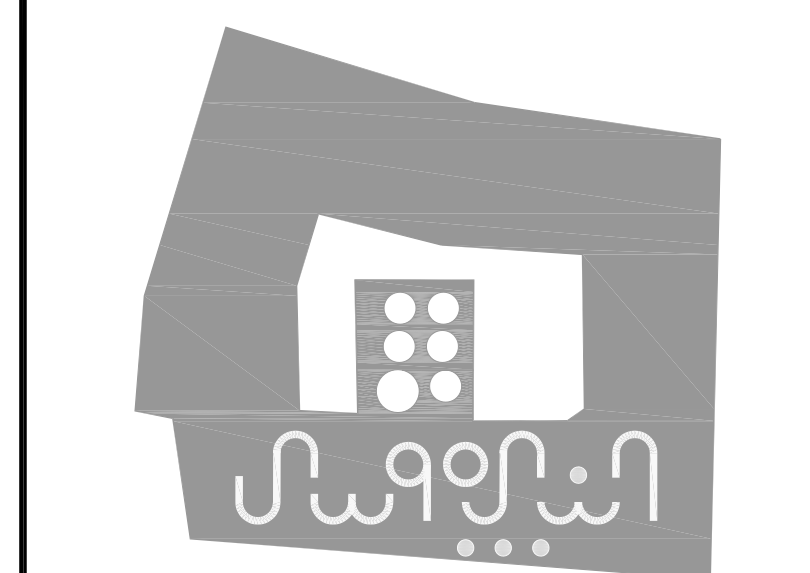

PROJECT:

Securing Professional Services for the Architectural Restoration and Rehabilitation Designs, Archaeological Documentation and Orientation Training, Including Tender Documents Preparation and Site Supervision for Conservation and Rehabilitation Works of Maqam Al-Nabi Musa in Jericho Governorate

Support to Development of Cultural Tourism

DESIGN WORKS:

-Jerusalem Design Center

ELECTRICAL WORKS:

-Eng .Midhat AlSharif


MECHANICAL WORKS:

-Elite Mechanical Consultants

SHEET NAME:

Ground Floor
Earthring System

SCALE: 1:100 if plotted on A0	EDITION:
☐ For Review	SHEET NO.
☐ For Approval	
☒ For Tender	
☐ For Construction	
DATE: July-2016	

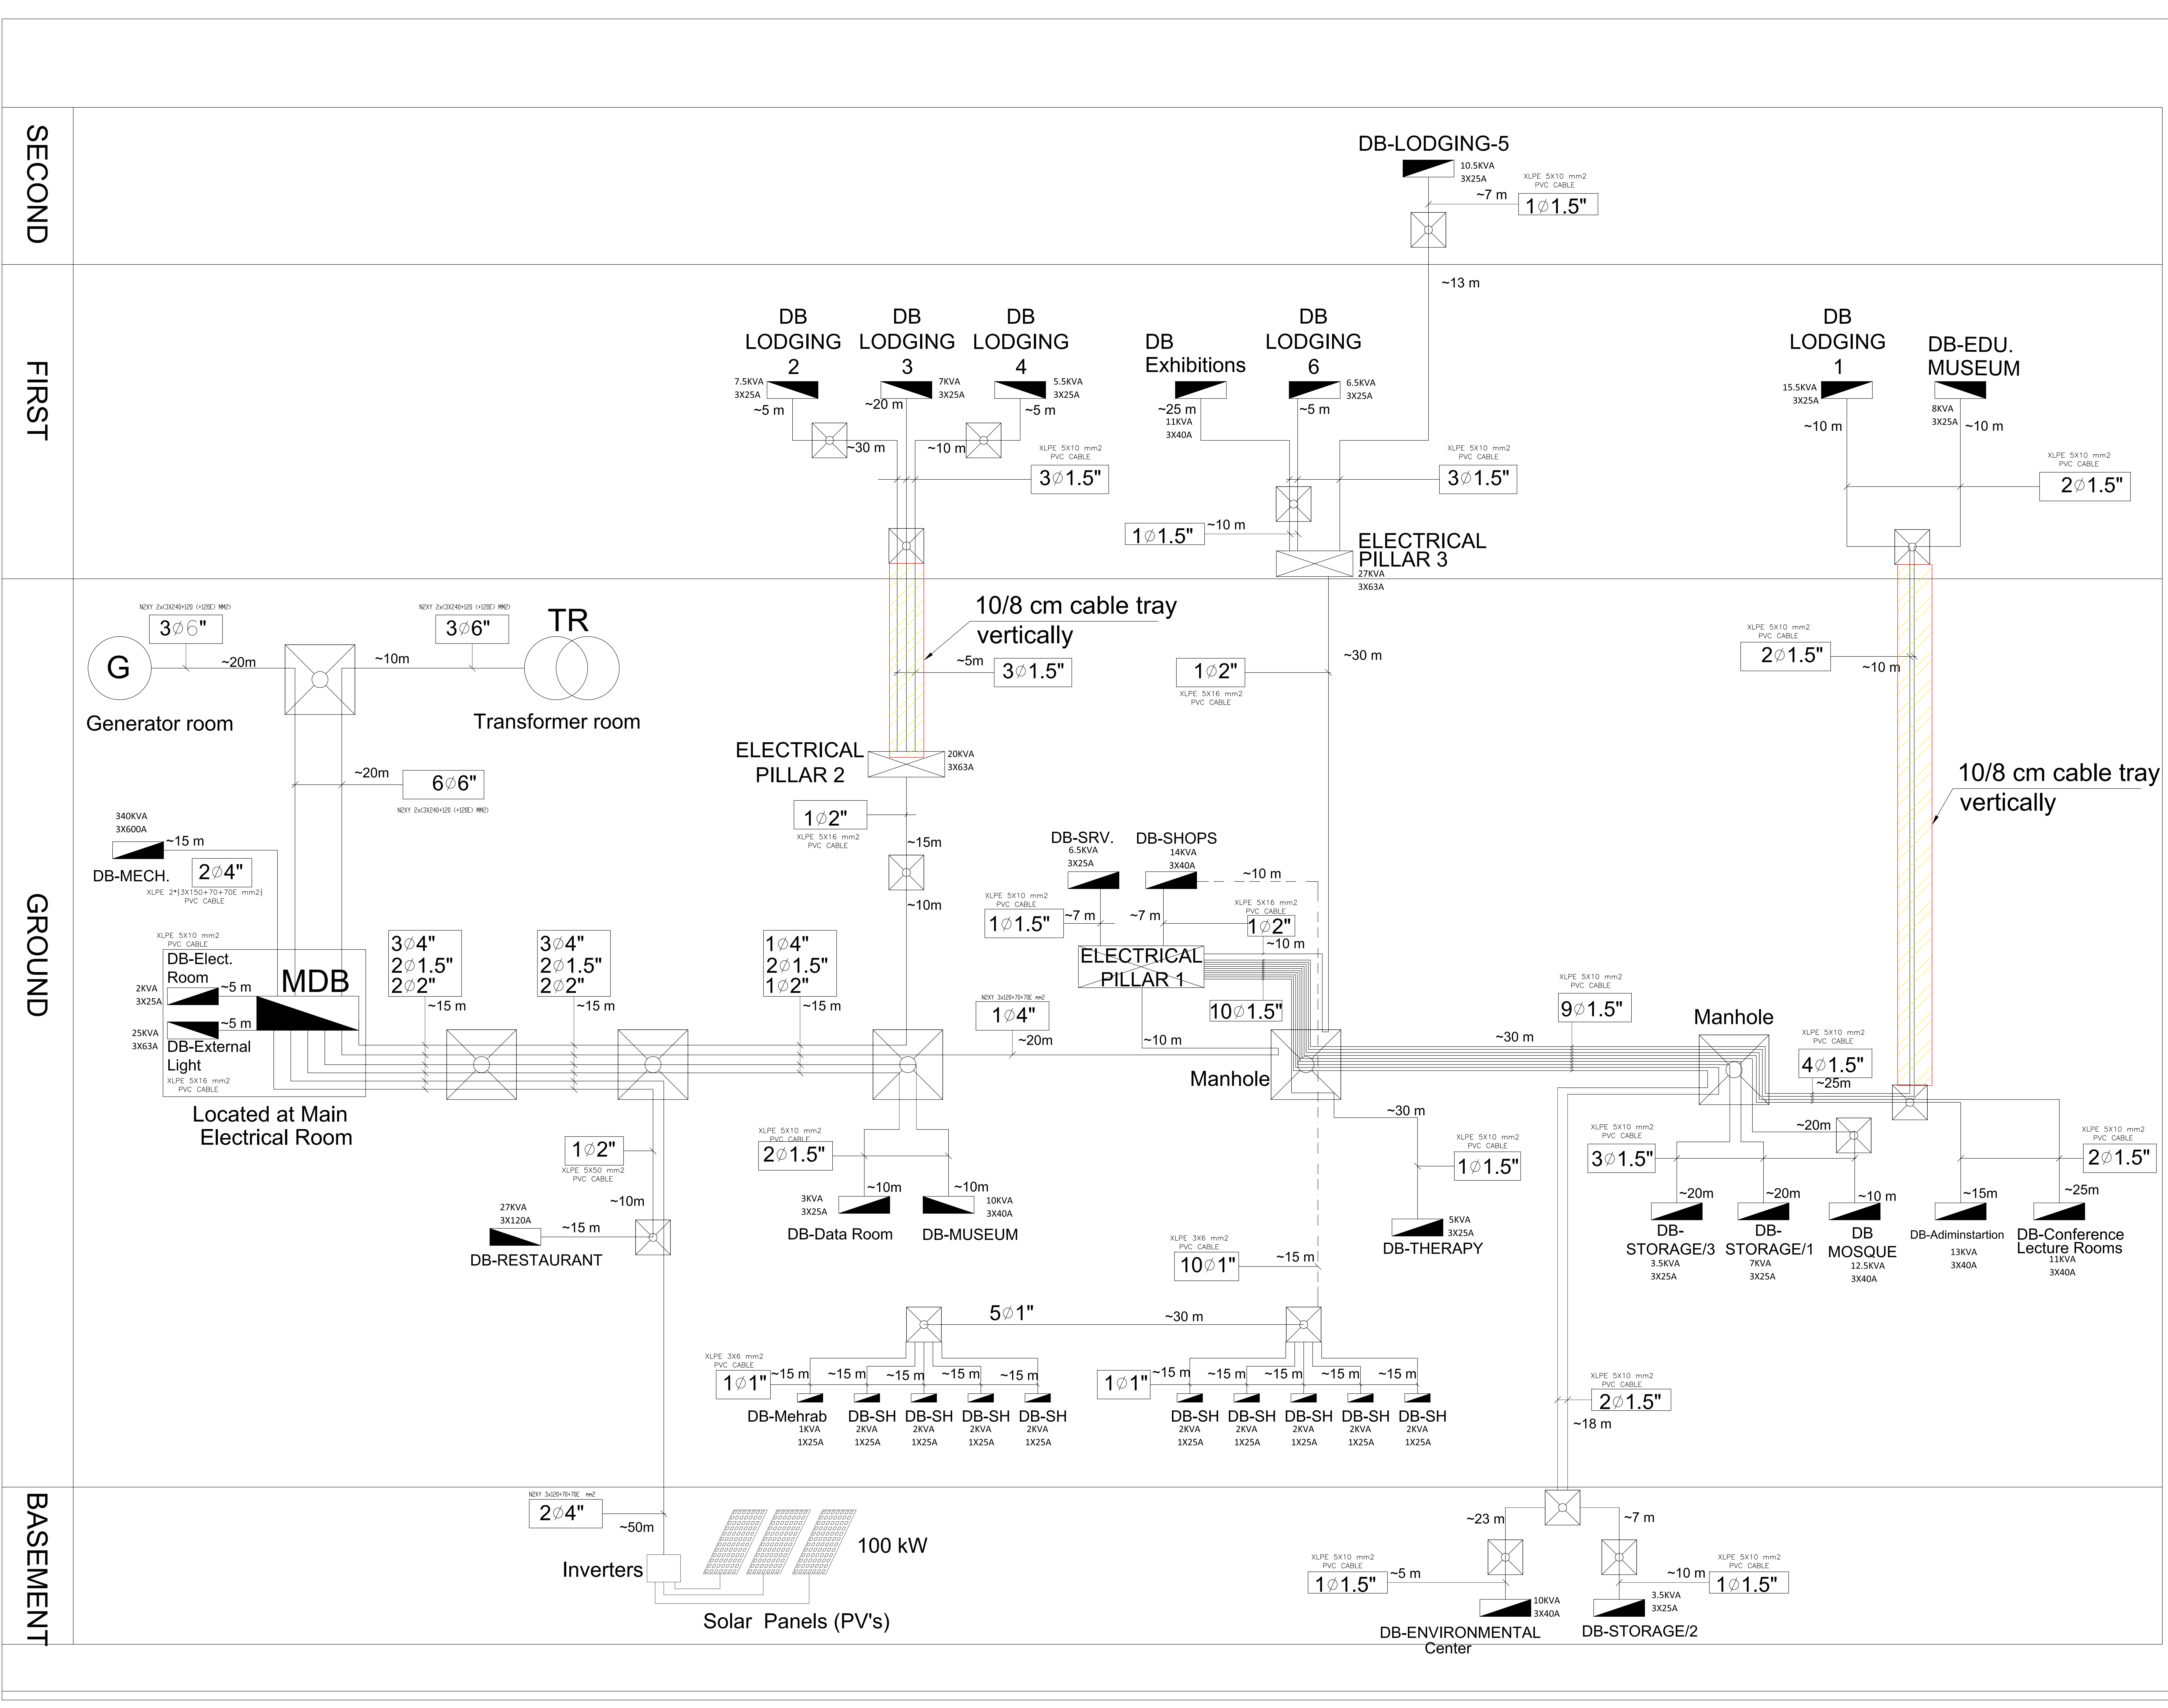

NOTES & LEGEND:

SYMBOL	DESCRIPTION
	THREE/SINGLE PHASE
	MAIN ELECTRIC BOARD LV. SIDE
	METAL ELECTRIC BOARD WITH LOW VOLTAGE SIDE
	DISTRIBUTION BOARD
	GENERATOR
	STEP RELAY
	MOTORIZED AIR CIRCUIT BREAKER WITH TRIP RATING
	CONTACTOR
	INDICATOR LAMPS WITH PUSH BUTTON
	GENERAL MULTIMETER
	AMETER/VOLTMETER
	TRANSFORMER
	THREE/SINGLE PHASE FUSE
	THREE/SINGLE PHASE EARTH LEAKAGE RELAY
	THREE PHASE KWHM
	SINGLE PHASE KWHM
	4-POLE CHANGE OVER SWITCH MANUAL OR AUTO
	CHECK BOX
	60*60CM ELECTRICAL MANHOLE
	60*60CM TELEPHONE MANHOLE

PROJECT:

Securing Professional Services for the Architectural Restoration and Rehabilitation Designs, Archaeological Documentation and Orientation Training, Including Tender Documents Preparation and Site Supervision for Conservation and Rehabilitation Works of Maqam Al-Nabi Musa in Jericho Governorate

Support to Development of Cultural Tourism

DESIGN WORKS:

-Jerusalem Design Center

ELECTRICAL WORKS:

-Eng .Midhat AlSharif

MECHANICAL WORKS:

-Elite Mechanical Consultants

SHEET NAME:

Power Riser

SCALE:


☐ For Review
☐ For Approval
☒ For Tender
☐ For Construction

EDITION:


SHEET NO.

DATE: July-2016

JerusalemDesignCenter
Architects, Engineers & Consultants
(Phone: 02-234 3636 | Fax: 02-234 3710 | Email: info@jdc.ps)

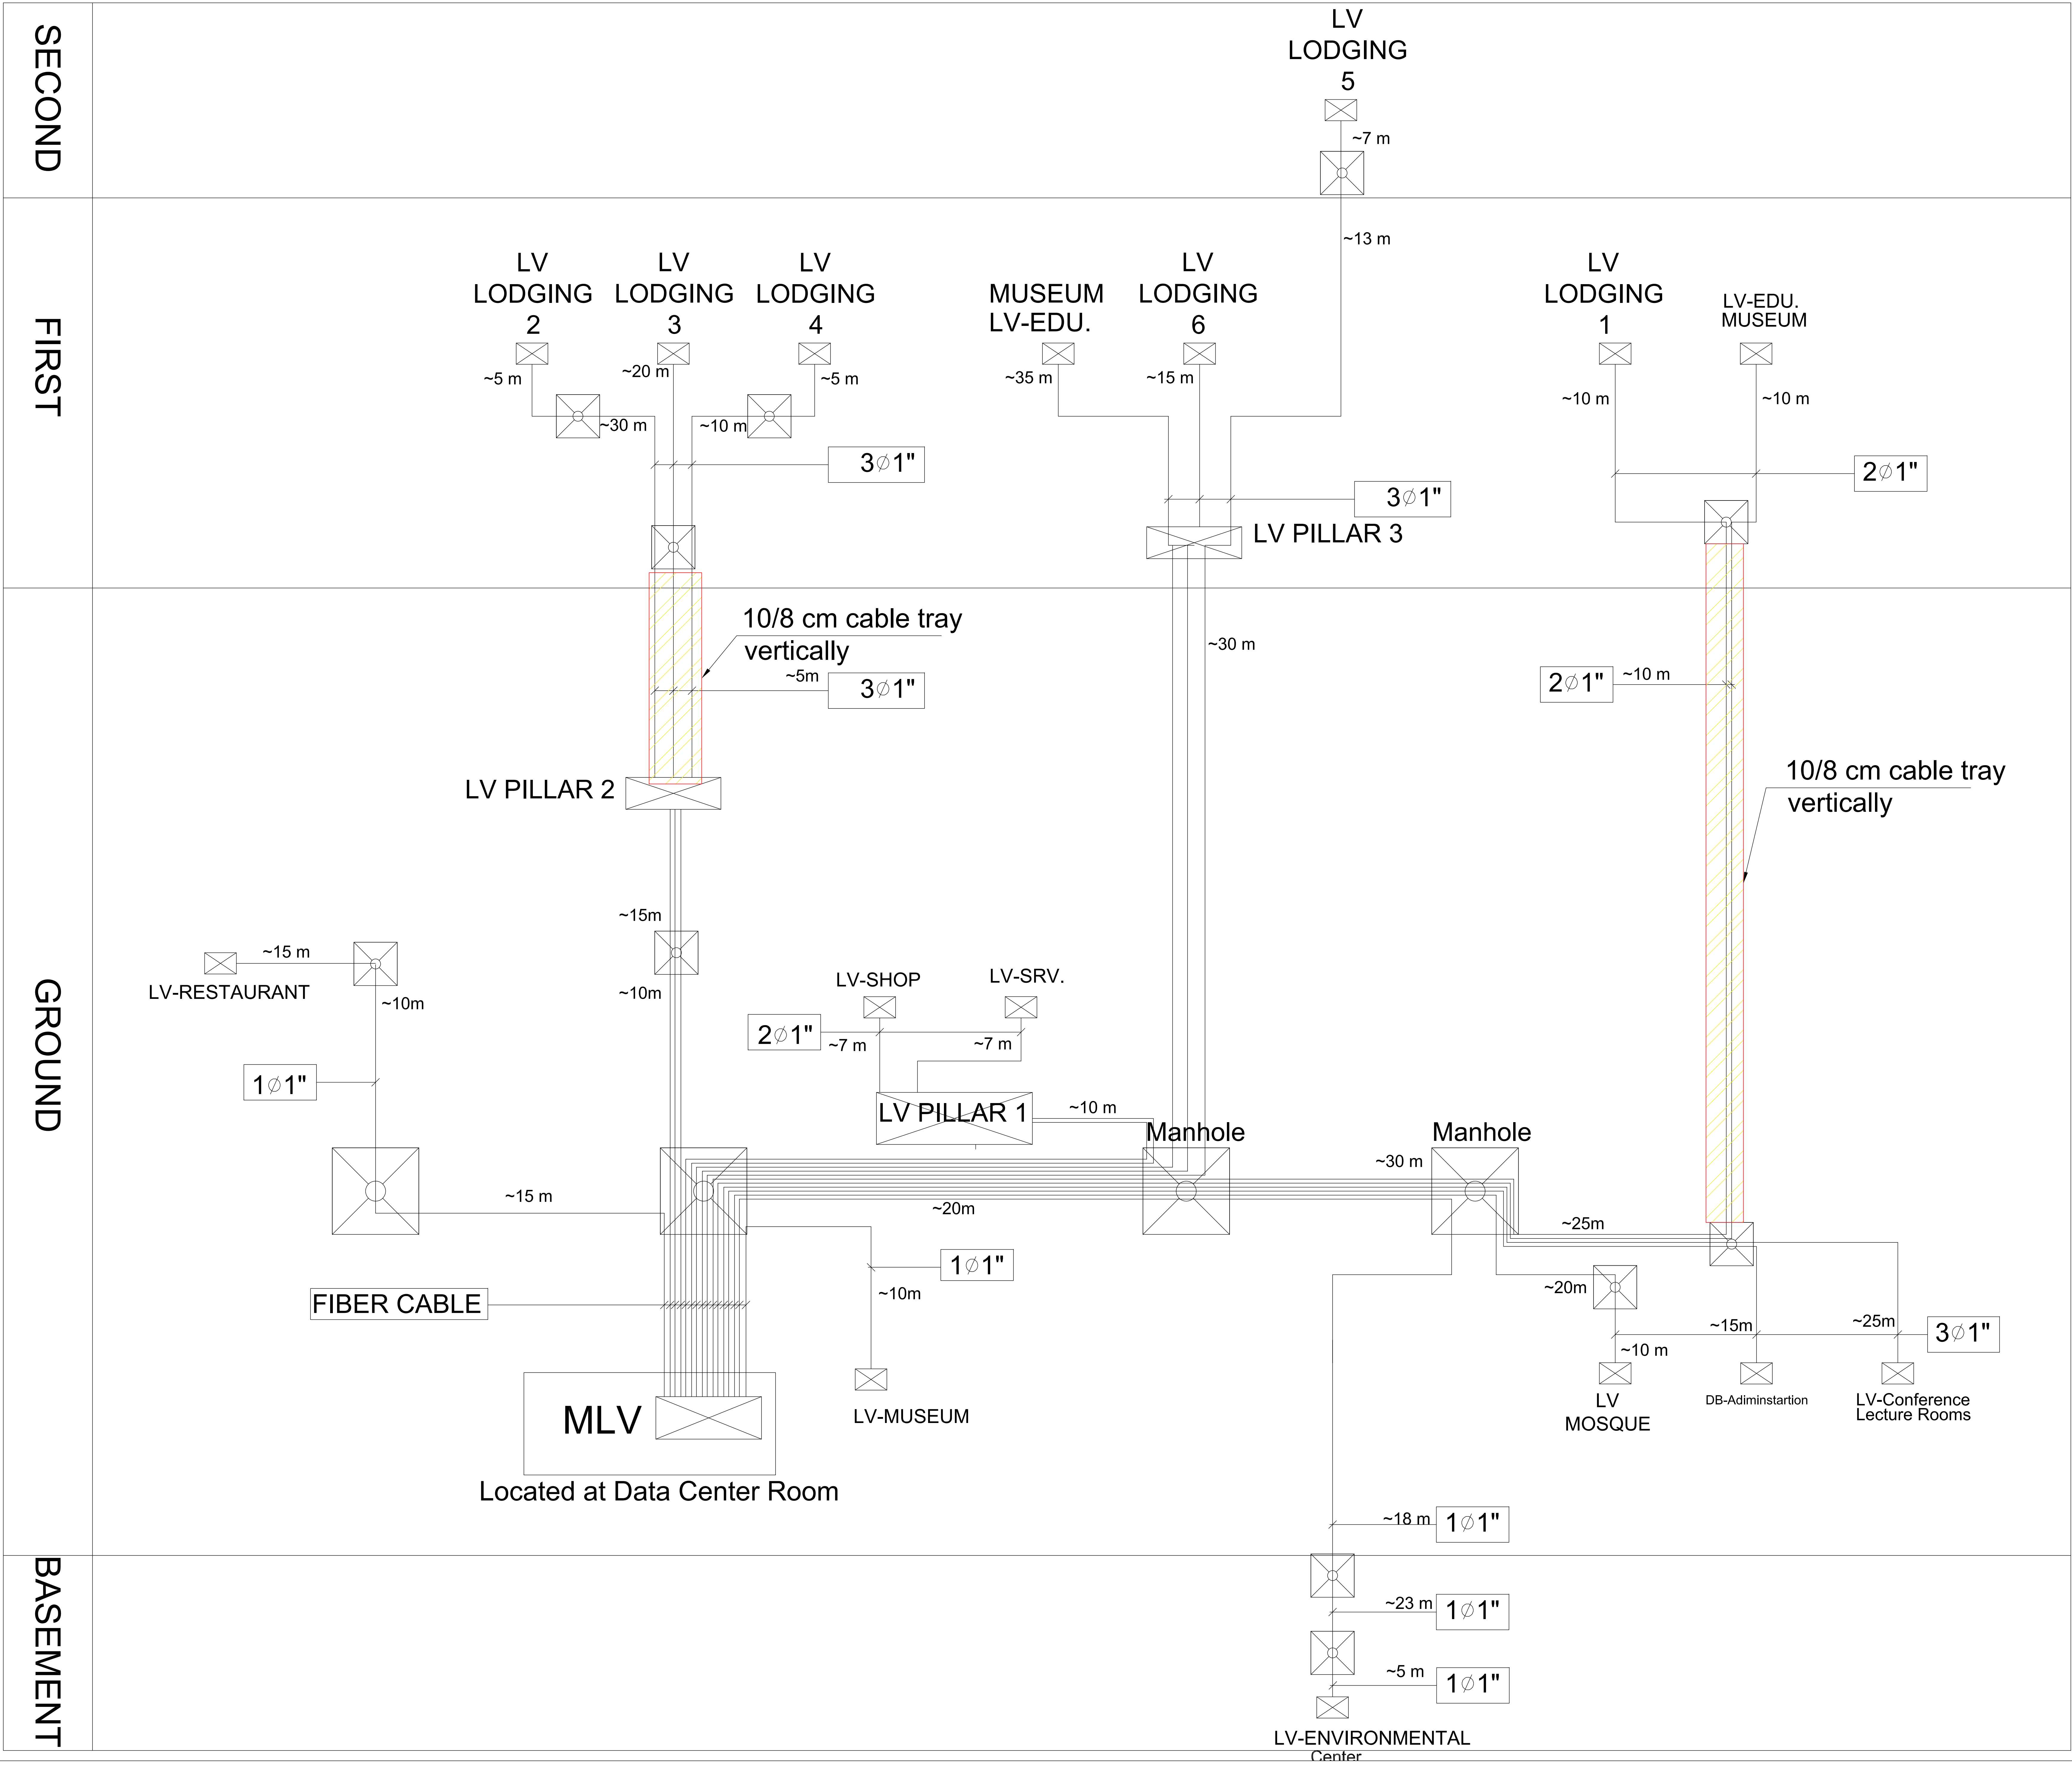

NOTES & LEGEND:	
SYMBOL	DESCRIPTION
	THREE/SINGLE PHASE
	MAIN ELECTRIC BOARD LV. SIDE
	METAL ELECTRIC BOARD WITH LOW VOLTAGE SIDE
	DISTRIBUTION BOARD
	GENERATOR
	STEP RELAY
	MOTORIZED AIR CIRCUIT BREAKER WITH TRIP RATING
	CONTACTOR
	INDICATOR LAMPS WITH PUSH BUTTON
	GENERAL MULTIMETER
	AMETER/VOLTMETER
	TRANSFORMER
	THREE/SINGLE PHASE FUSE
	THREE/SINGLE PHASE EARTH LEAKAGE RELAY
	THREE PHASE KWHM
	SINGLE PHASE KWHM
	4-POLE CHANGE OVER SWITCH MANUAL OR AUTO
	CHECK BOX
	60*60CM ELECTRICAL MANHOLE
	60*60CM TELEPHONE MANHOLE

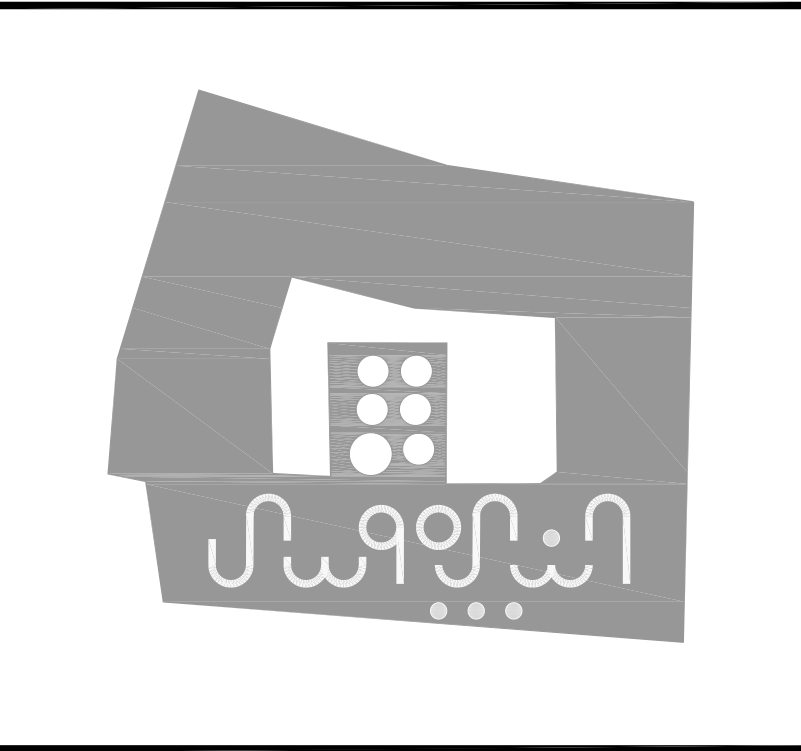

PROJECT:
Securing Professional Services for the Architectural Restoration and Rehabilitation Designs, Archaeological Documentation and Orientation Training, Including Tender Documents Preparation and Site Supervision for Conservation and Rehabilitation Works of Maqam Al-Nabi Musa in Jericho Governorate
Support to Development of Cultural Tourism

DESIGN WORKS:
-Jerusalem Design Center

ELECTRICAL WORKS:
-Eng .Midhat AlSharif

MECHANICAL WORKS:
-Elite Mechanical Consultants

SHEET NAME:
LV Riser

SCALE:	EDITION:
☐ For Review ☐ For Approval ☒ For Tender ☐ For Construction	SHEET NO.
DATE: July-2016	


ROOF

SECOND

















FIRST

GROUND


BASEMENT

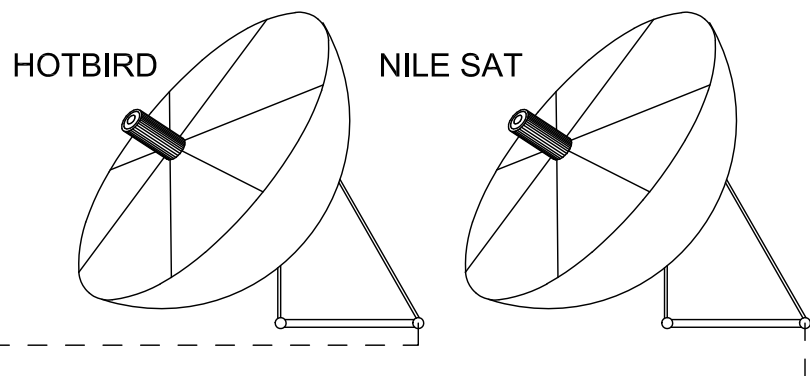

to LV Room

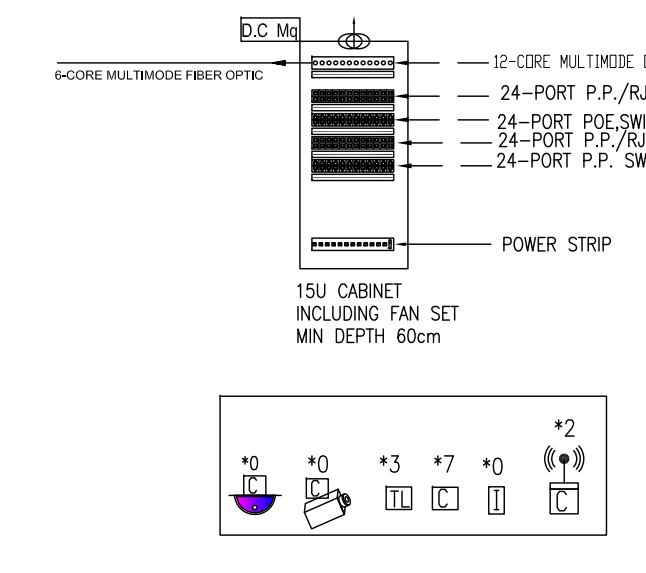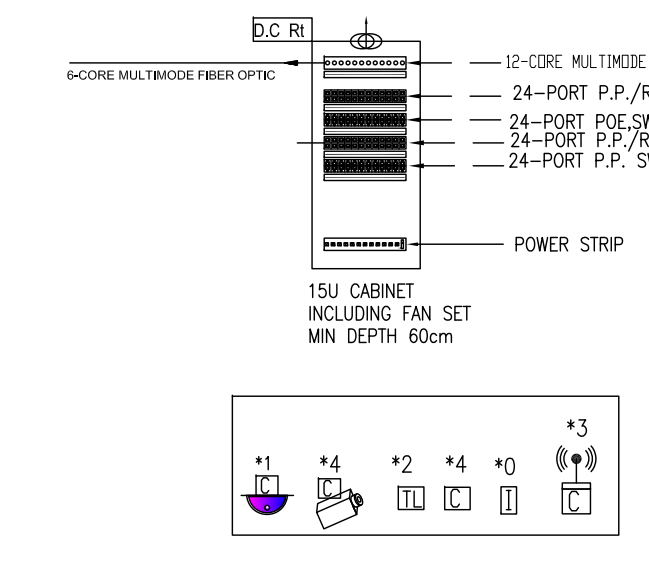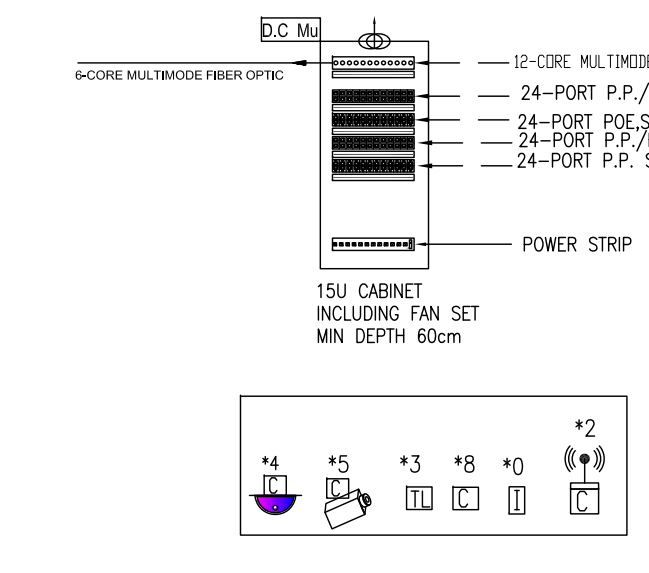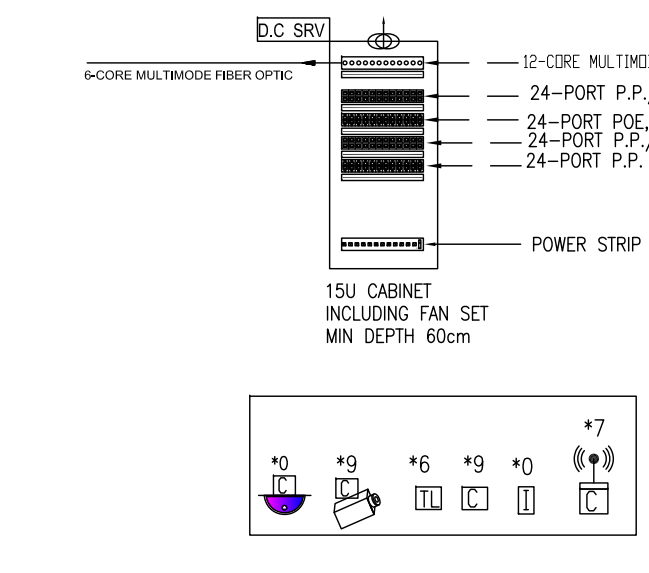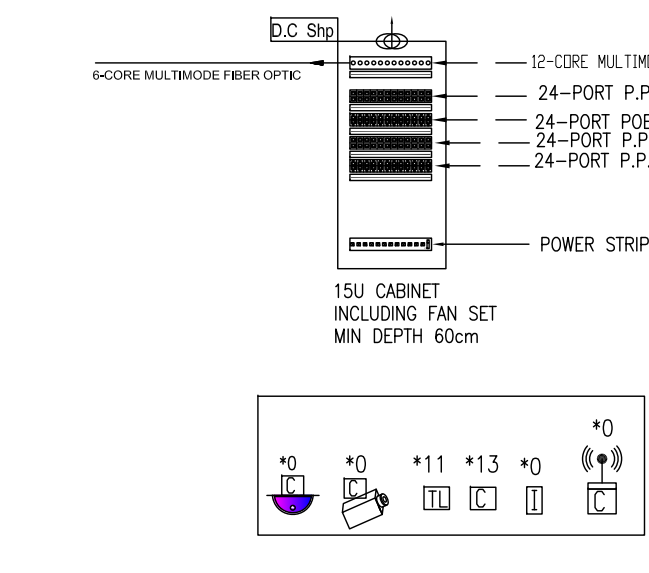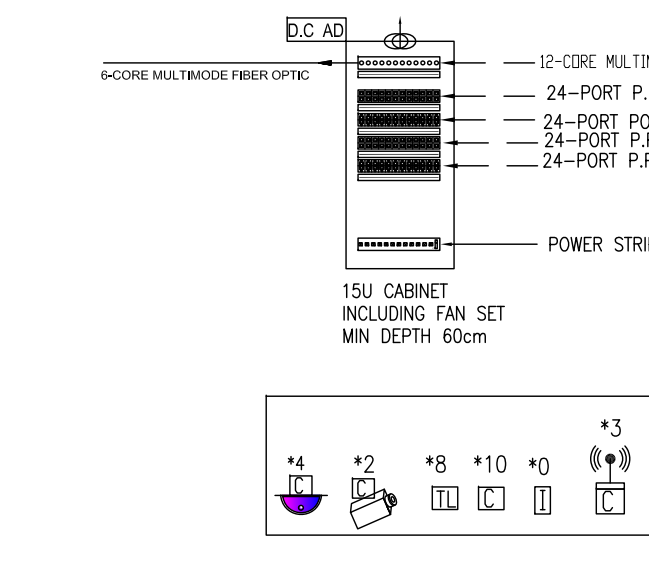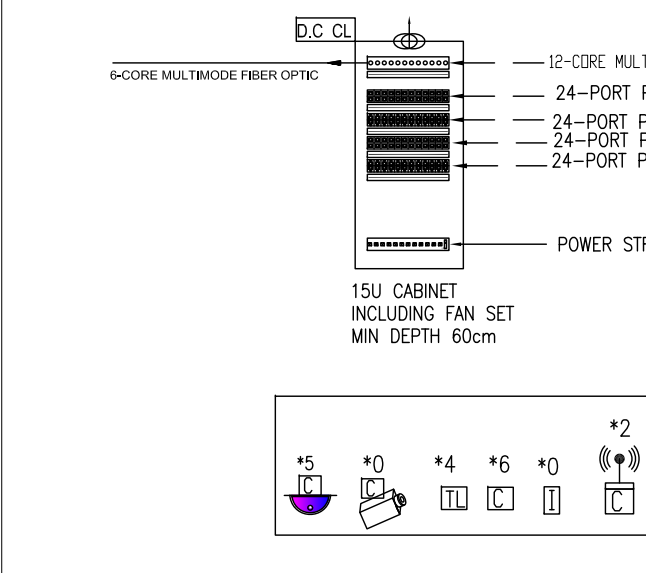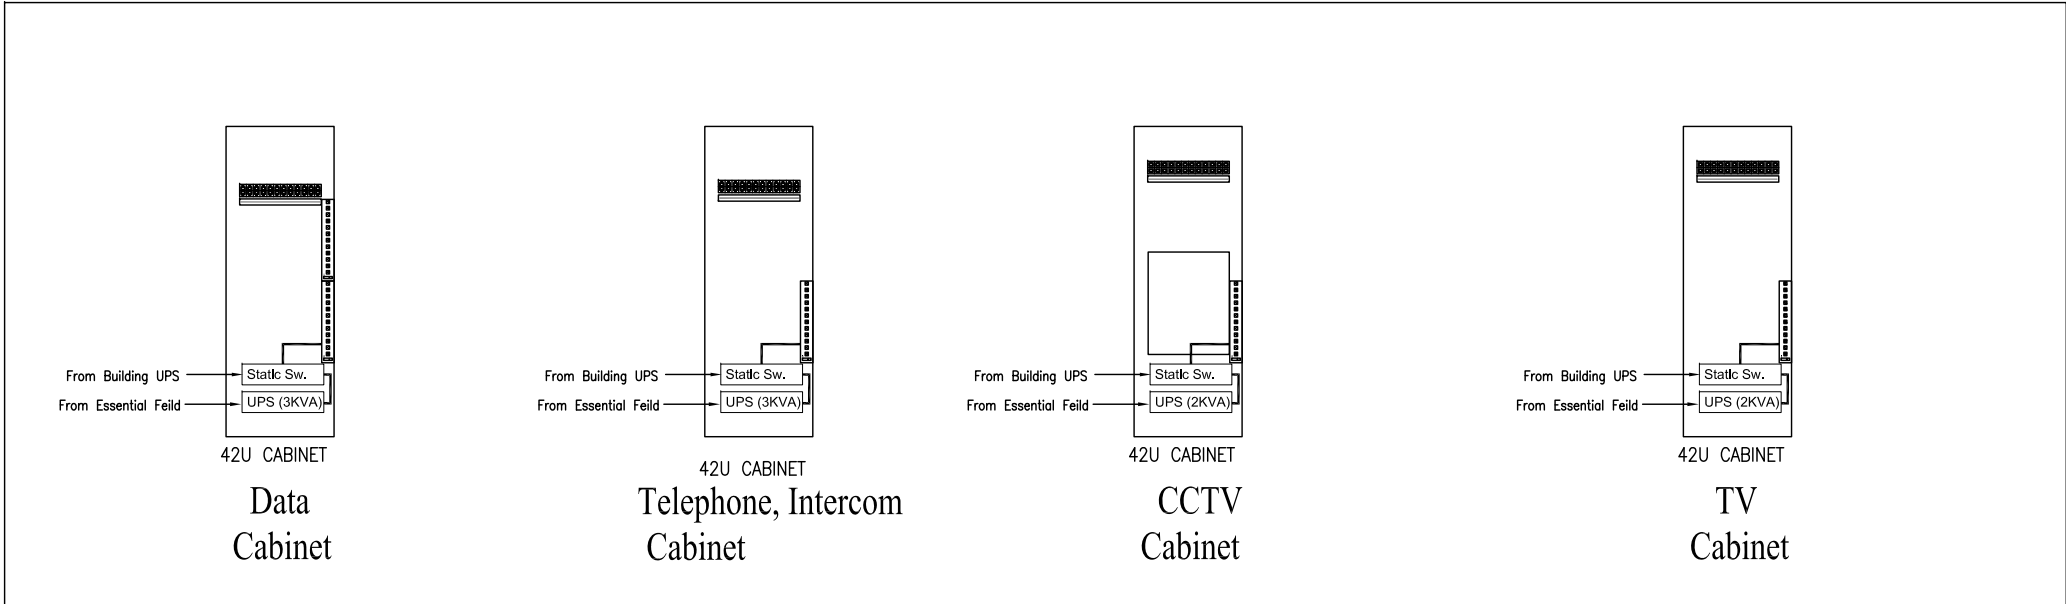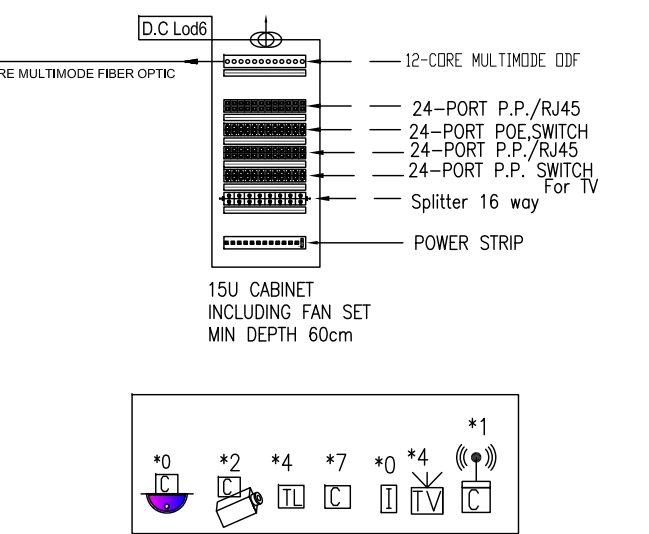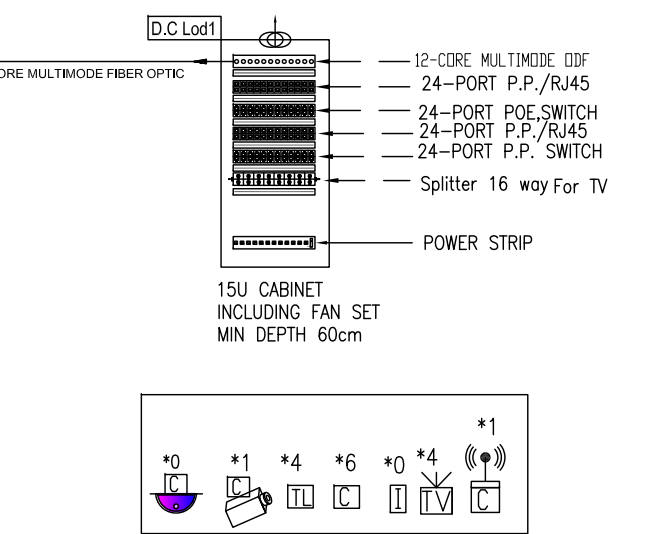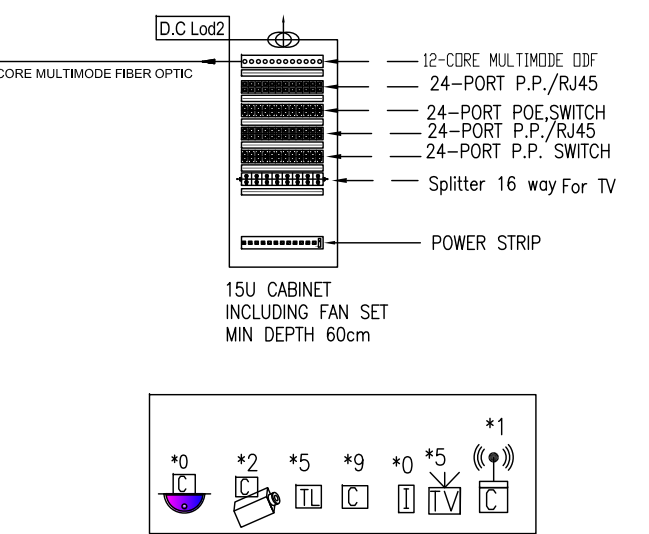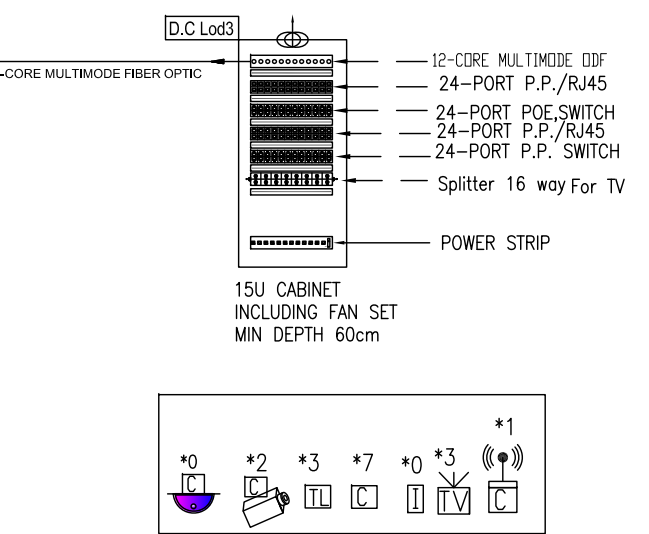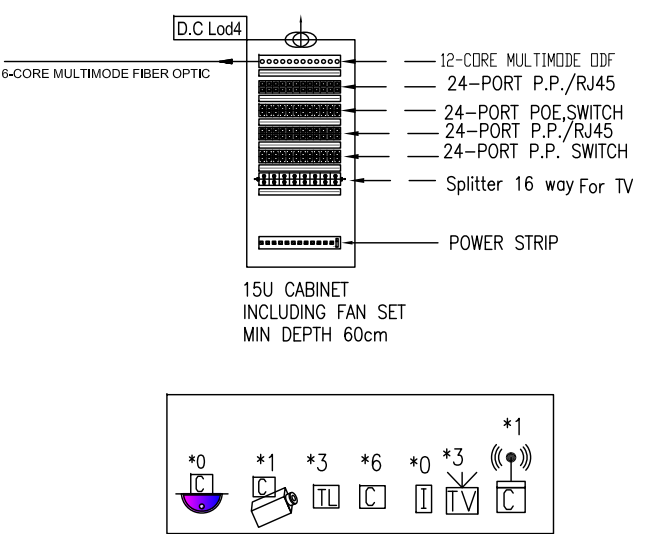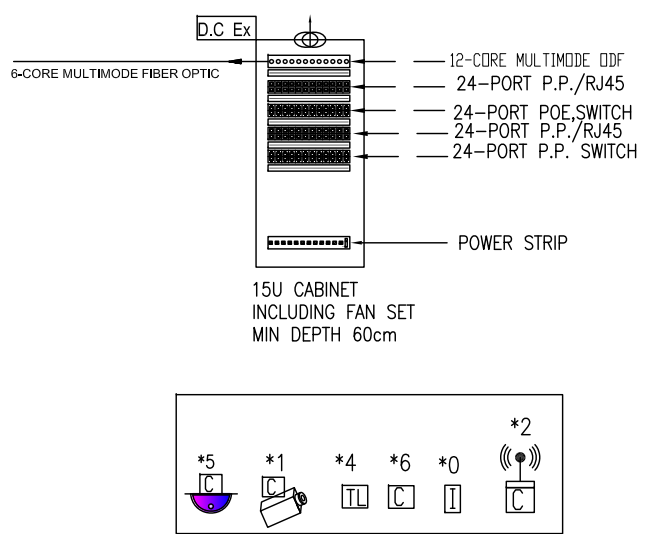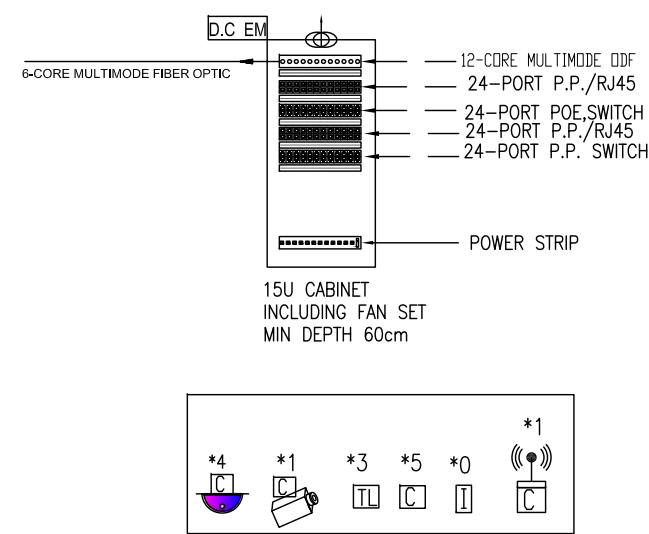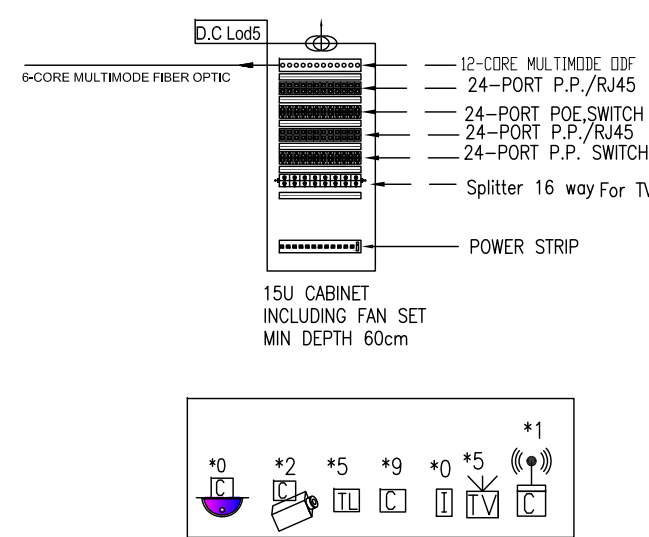


LV Room "Data Center"

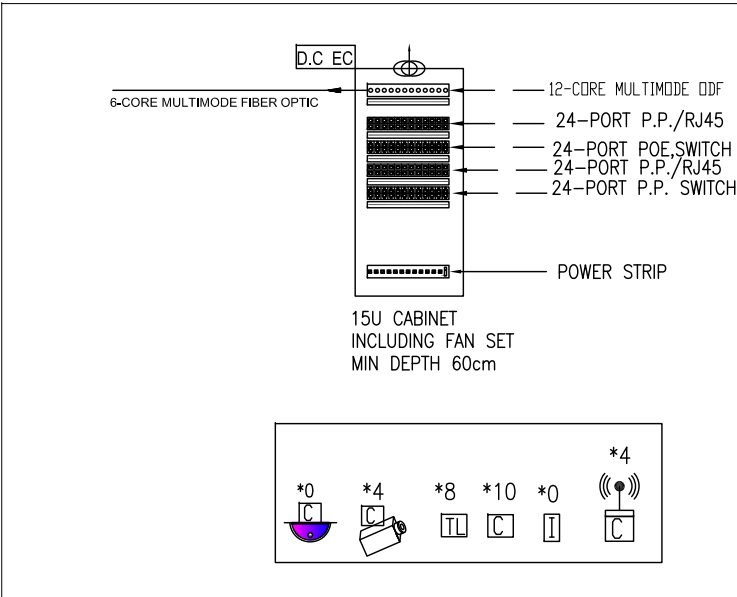

15	CAT6	PSE
12	CAT6	PSE
10	CAT6	PSE
8	CAT6	Non PSE
6	CAT6	PSE
4	CAT6	PSE
2	RG59	

NOTES & LEGEND:	
SYMBOL	DESCRIPTION
	L.V. SOCKETS
	TELEPHONE SOCKET OUTLET
	T.V. SOCKET OUTLET
	DATA SOCKET OUTLET
	LOW VOLTAGE BOX
	COMPUTER PATCH PANEL
	INTERCOM
	Wifi-Point
	Data Cabinet
	15 12 10 8 6 4 2 1
	15 12 10 8 6 4 2 1
	PROJECTOR
	VISA
	CCTV SYSTEM
	100% INDOOR COLORED CAMERA
	FIXED OUTDOOR COLORED CAMERA DAY/NIGHT
	SPLIT SCREEN MONITOR
	CCTV CENTRAL MONITOR

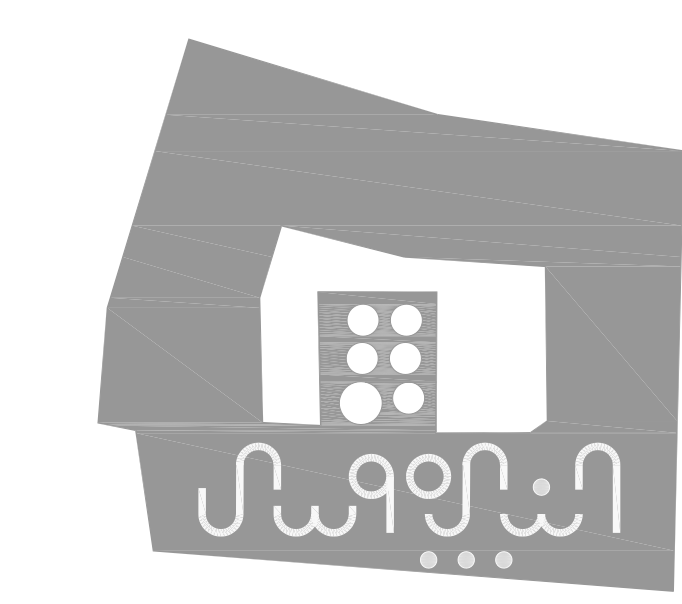

PROJECT:

Securing Professional Services for the Architectural Restoration and Rehabilitation Designs, Archaeological Documentation and Orientation Training, Including Tender Documents Preparation and Site Supervision for Conservation and Rehabilitation Works of Maqam Al-Nabi Musa in Jericho Governorate

Support to Development of Cultural Tourism

DESIGN WORKS:

-Jerusalem Design Center

ELECTRICAL WORKS:

-Eng .Midhat AlSharif

MECHANICAL WORKS:

-Elite Mechanical Consultants

SHEET NAME:

Data Cabinet Riser

SCALE:


EDITION:

For Review
For Approval
For Tender
For Construction

SHEET NO.

30

DATE: July-2016

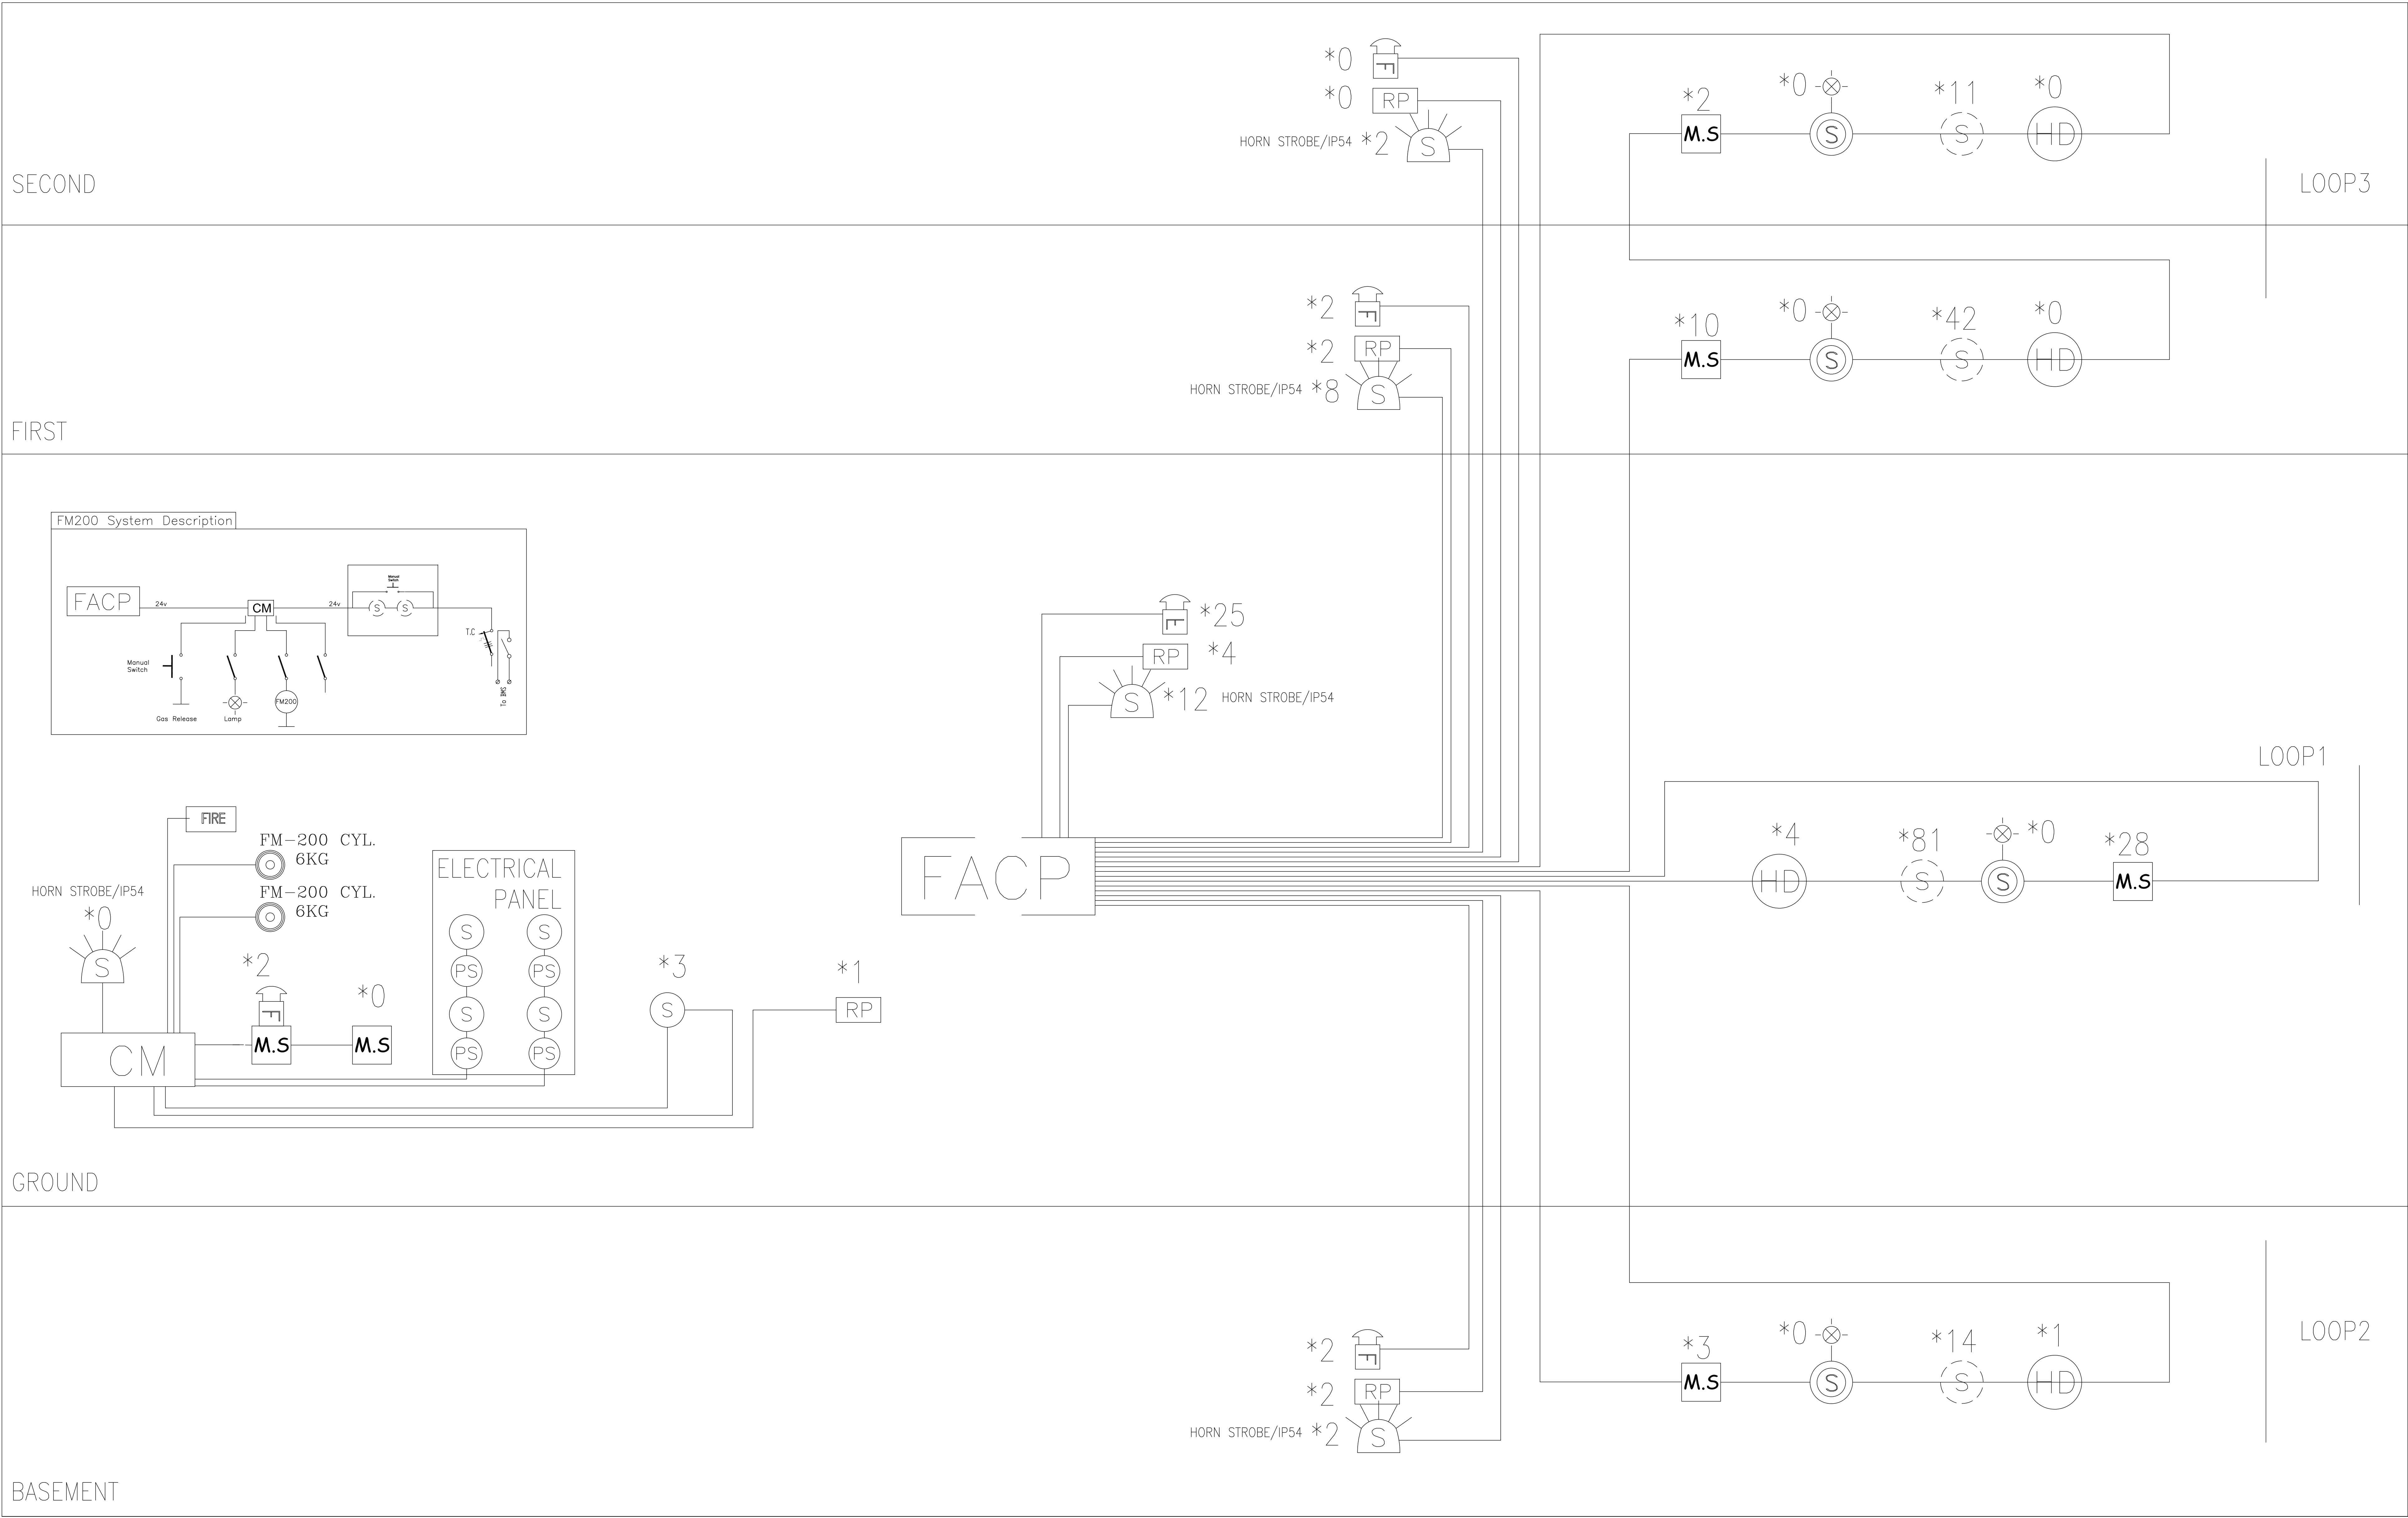

NOTES & LEGEND:

SYMBOL	DESCRIPTION	
FIRE ALARM SYSTEM		
	PHOTO SMOKE SENSOR	CEILING
	HEAT DETECTOR	CEILING
	BREAK GLASS	150
	INTERNAL SIREN	220
	CONTROL MODULE	CEILING
	EXTERNAL SIREN WITH FLASHER	220
	Beam Detector-Receiver	
	Beam Detector-Transmitter	
	DETECTOR INDICATION LAMP	CEILING
	PHOTOELECTRIC SMOKE DET. ABOVE FAULSCEILING	CEILING
	FIRE ALARM CONTROL PANEL	180
	REPEATER PANEL WITH CONTROL	150
	FIRE INDICATOR LAMP SIGN	CEILING

EUROPEAN UNION
UNDP
50 YEARS
دولة فلسطين
Empowered lives. Resilient nations.
دولة فلسطين
مجلس إدارة

PROJECT:

Securing Professional Services for the Architectural Restoration and Rehabilitation Designs, Archaeological Documentation and Orientation Training, Including Tender Documents Preparation and Site Supervision for Conservation and Rehabilitation Works of Maqam Al-Nabi Musa in Jericho Governorate

Support to Development of Cultural Tourism

DESIGN WORKS:

-Jerusalem Design Center

ELECTRICAL WORKS:

-Eng .Midhat AlSharif

MECHANICAL WORKS:

-Elite Mechanical Consultants

SHEET NAME:

Fire Alarm Riser

SCALE:

☐ For Review
☐ For Approval
☒ For Tender
☐ For Construction

EDITION:

SHEET NO.

E-31

JerusalemDesignCenter
Architects, Engineers & Consultants

Phone: 02-234 3696 | Fax: 02-234 3710 | Email: info@jdc.ps


ROOF

SECOND

FIRST


GROUND

BASEMENT

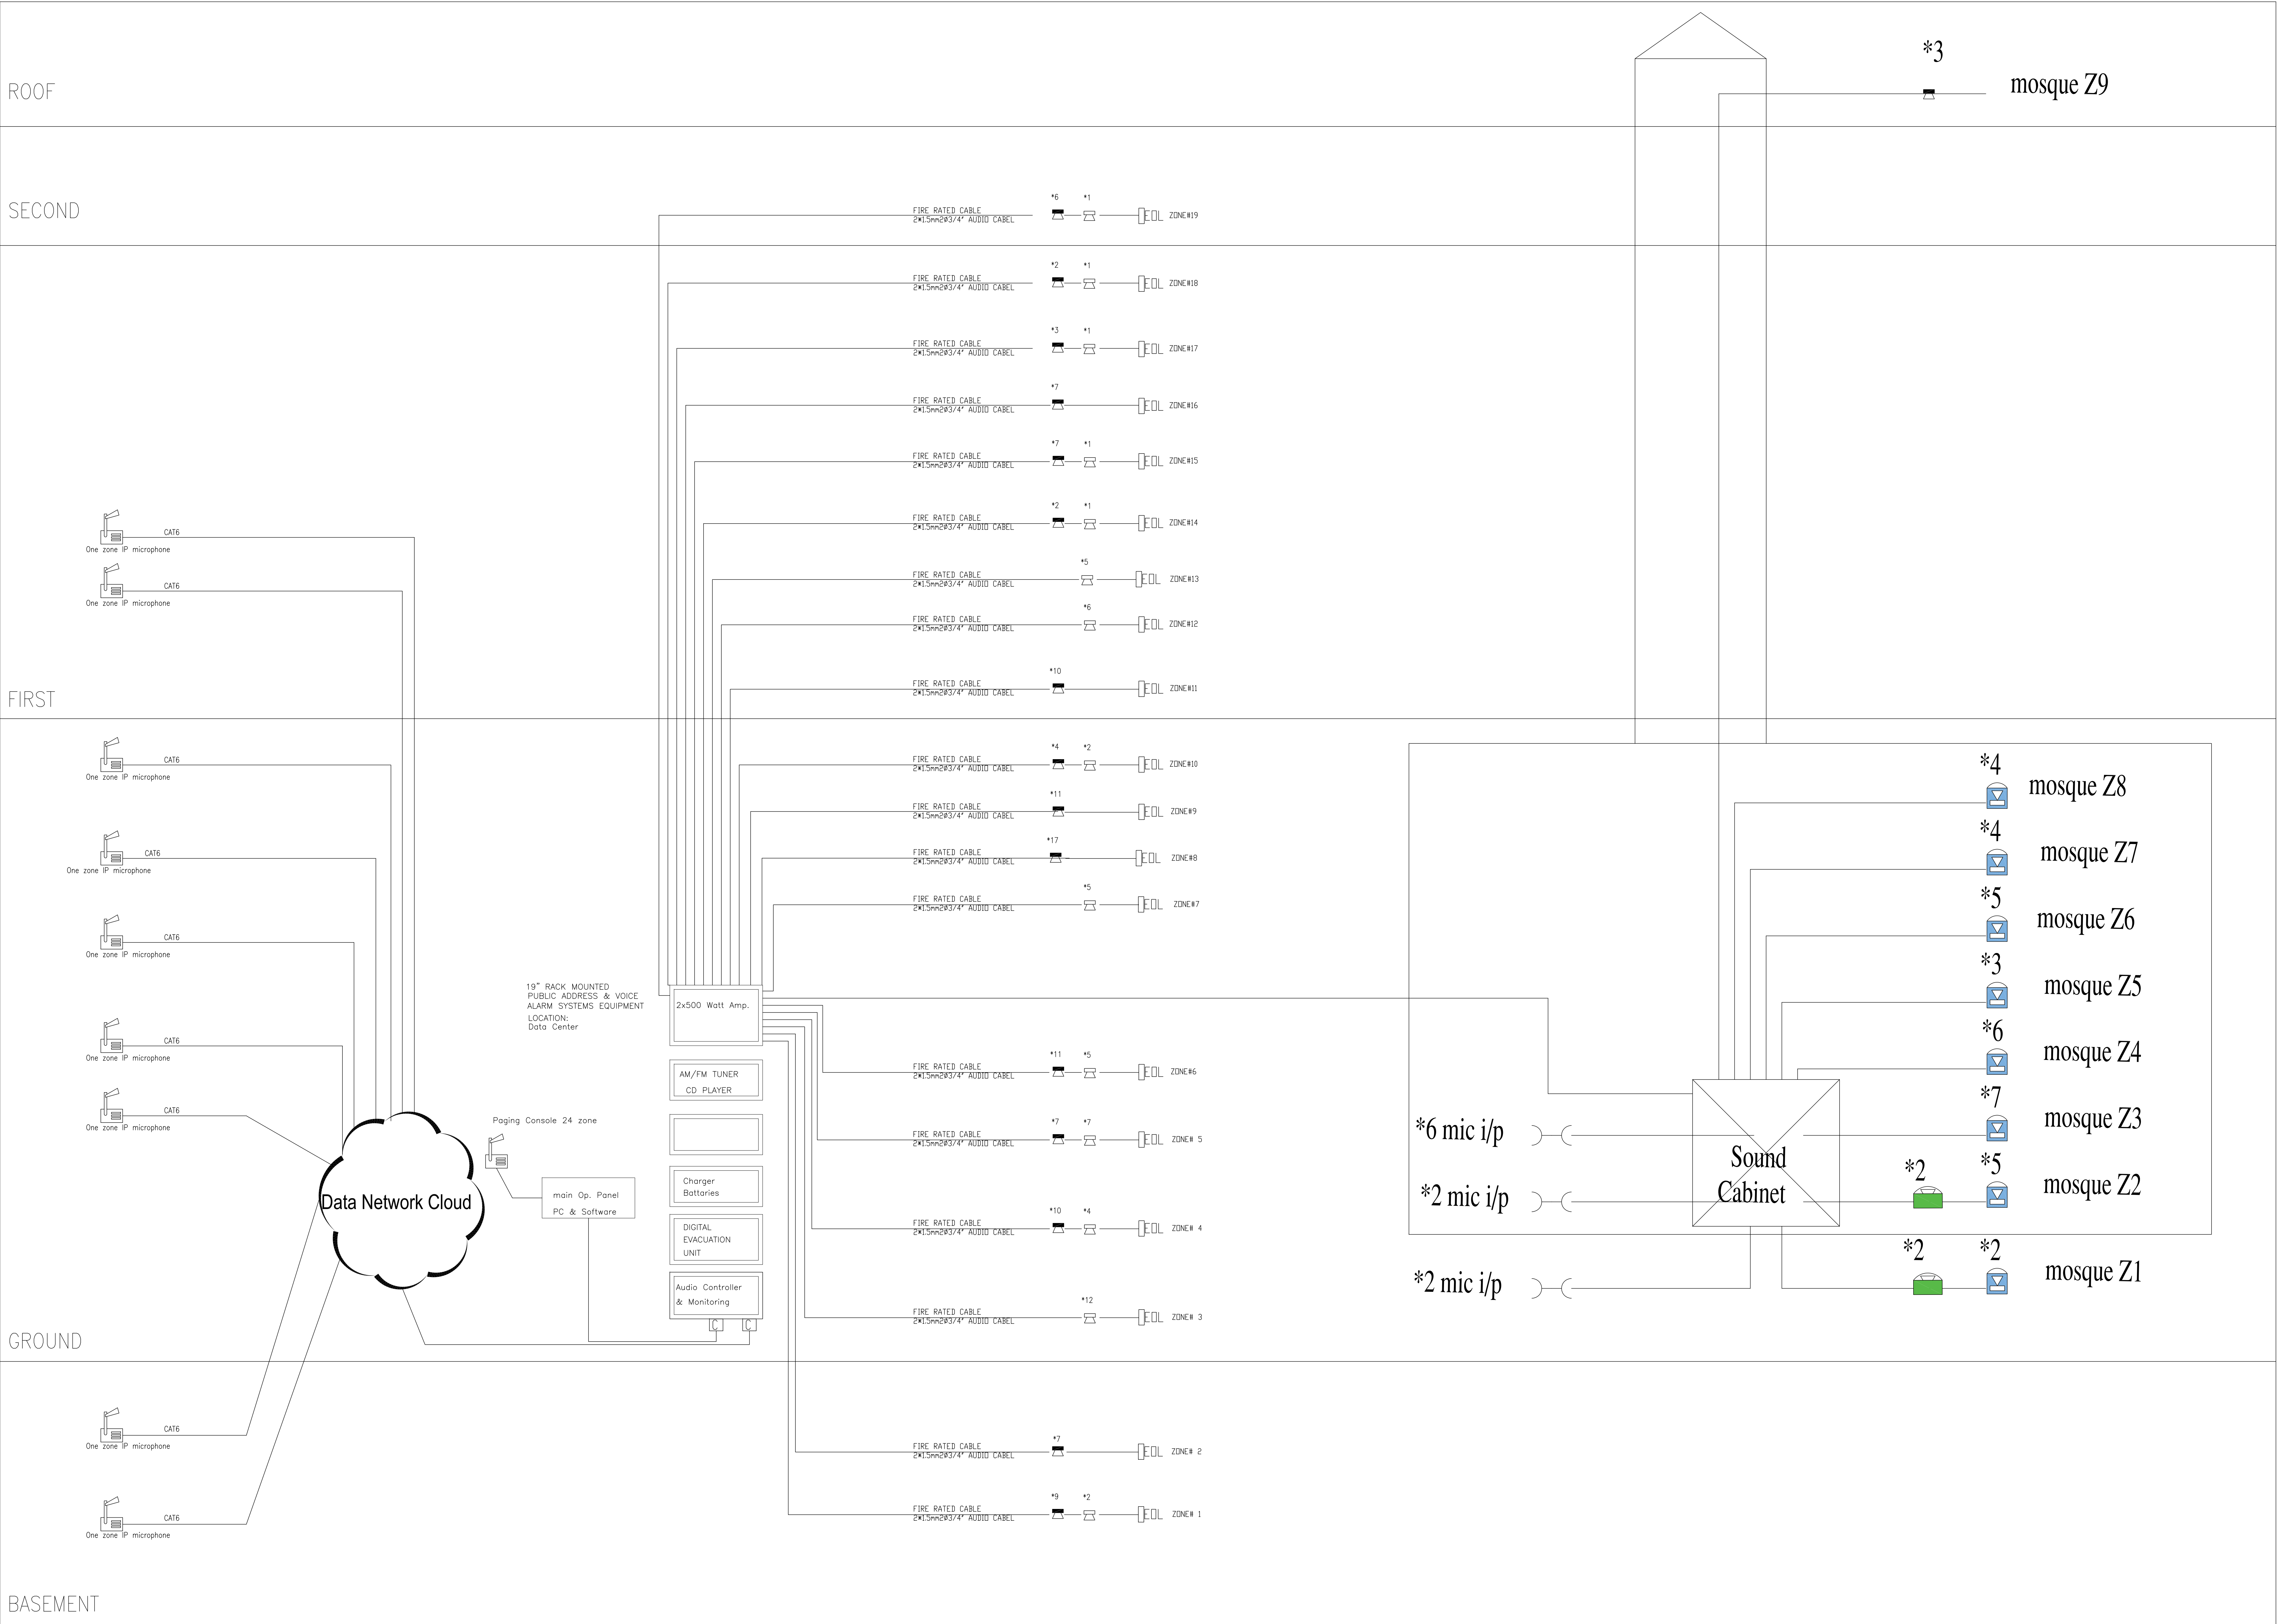

NOTES & LEGEND:

SYMBOL	DESCRIPTION	
	SOUND SYSTEM	H= (cm) a.f.f.
	6WATT RECESSED LOUD SPEAKER	CEILING
	6WATT SURFACE MOUNT LOUD SPEAKER	220
	25W WALL MOUNTED ADJUSTABLE HORN	220
	END OF THE LINE	CEILING
	VOLUME CONTROL	150
	16 BUTTON CALL STATION	Table
	P.A.V.A. PUBLIC ADDRESS AND VOICE ALARM RACK	180
	PENDANT SPEAKER	
	CEILING SPEAKER	
	WALL MOUNT SPEAKER	
	COLUMN SPEAKER 0.5M	
	COLUMN SPEAKER 1.0M	
	HORN SPEAKER	
	Horn speaker 2 way	
	Microphone XLR box	
	Zone No.	
	42 U rack cabinet	

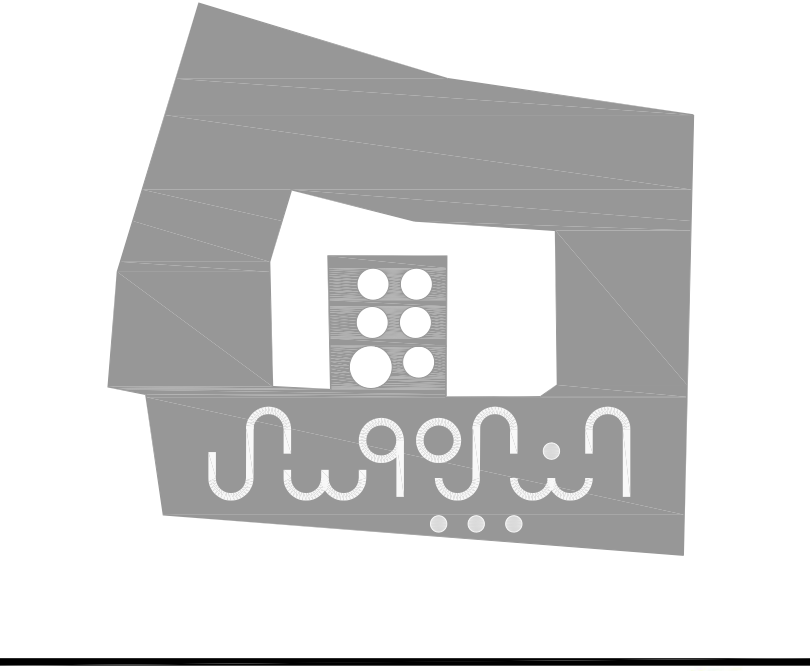

EUROPEAN UNION
UN DP
50 YEARS
الدولة الفلسطينية
Empowered lives. Resilient nations.

PROJECT:
Securing Professional Services for the Architectural Restoration and Rehabilitation Designs, Archaeological Documentation and Orientation Training, Including Tender Documents Preparation and Site Supervision for Conservation and Rehabilitation Works of Maqam Al-Nabi Musa in Jericho Governorate
Support to Development of Cultural Tourism

DESIGN WORKS:
JDC -Jerusalem Design Center

ELECTRICAL WORKS:
-Eng .Midhat AlSharif


MECHANICAL WORKS:
elite -Elite Mechanical Consultants

SHEET NAME:
Public Address System Riser

SCALE:
☐ For Review
☐ For Approval
☒ For Tender
☐ For Construction
DATE: July-2016

EDITION:
SHEET NO.
E-32

JDC Jerusalem Design Center
Architects, Engineers & Consultants
Phone: 02-234-3696 | Fax: 02-234-3710 | Email: info@jdc.jo

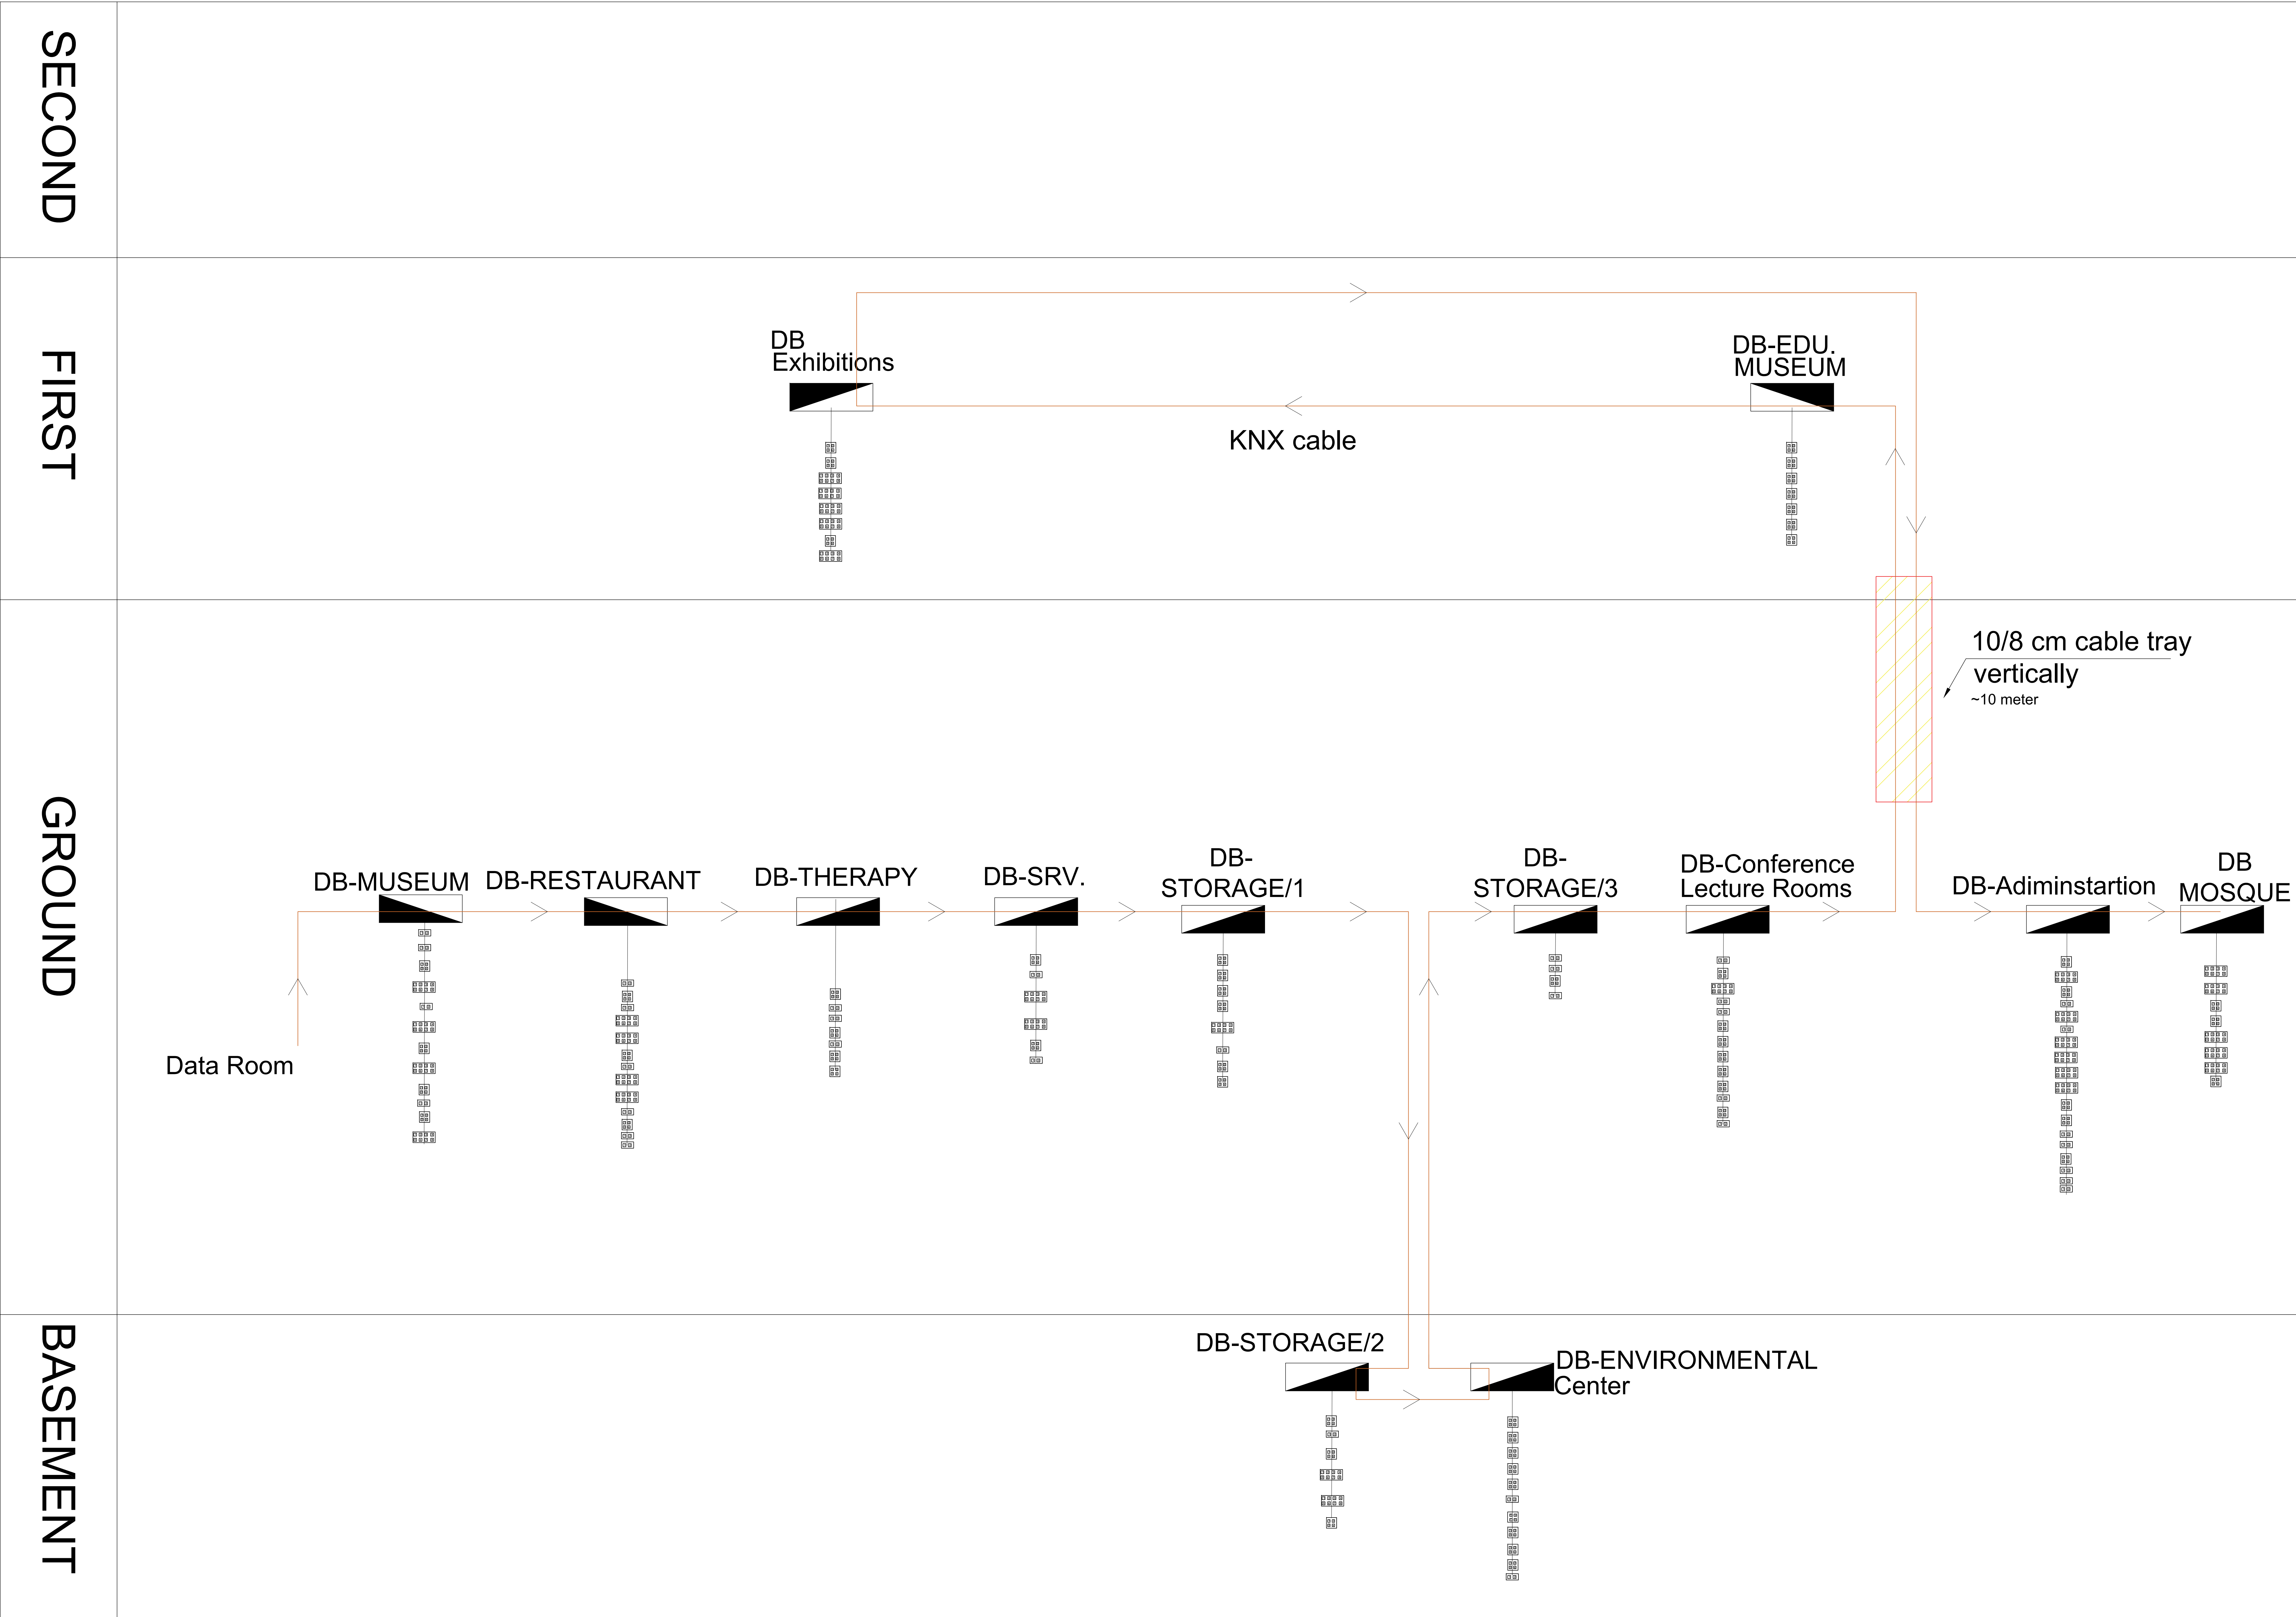

NOTES & LEGEND:		
PS		Power Supply Unit
AS		Automation Server Unit
DI16		Digital Input 16 Unit
DO12		Digital Output 12 Unit
UI/AO		Universal Input 8 Analog Output 4 Unit
PM 1200		Power Meter 1200
Loytec Panel		Loytec 10" Touch Panel
SC 3514		Voltage Switching Relay Pack
SE 7300		Room Control (With or Without Occupancy Sensor)
MPM UN		Multi-Purpose Manager

PROJECT:

Securing Professional Services for the Architectural Restoration and Rehabilitation Designs, Archaeological Documentation and Orientation Training, Including Tender Documents Preparation and Site Supervision for Conservation and Rehabilitation Works of Maqam Al-Nabi Musa in Jericho Governorate

Support to Development of Cultural Tourism

DESIGN WORKS:

-Jerusalem Design Center

ELECTRICAL WORKS:

-Eng .Midhat AlSharif

MECHANICAL WORKS:

-Elite Mechanical Consultants

SHEET NAME:

KNX RISER

SCALE:

☐ For Review
☐ For Approval
☒ For Tender
☐ For Construction

EDITION:



SHEET NO.

DATE: July-2016

Jerusalem Design Center
Architects, Engineers & Consultants

Phone: 02-234 3696 | Fax: 02-234 3710 | Email: info@jdc.ps

SYMBOL	DESCRIPTION
	THREE/SINGLE PHASE
	MAIN ELECTRIC BOARD L.V. SIDE
	METAL ELECTRIC BOARD WITH LOW VOLTAGE SIDE
	DISTRIBUTION BOARD
	GENERATOR
	STEP RELAY
	MOTORIZED AIR CIRCUIT BREAKER WITH TRIP RATING
	CONTACTOR
	INDICATOR LAMPS WITH PUSH BUTTON
	GENERAL MULTIMETER
	AMETER/VOLTMETER
	TRANSFORMER
	THREE/SINGLE PHASE FUSE
	THREE/SINGLE PHASE EARTH LEAKAGE RELAY
	THREE PHASE KWHM
	SINGLE PHASE KWHM
	4-POLE CHANGE OVER SWITCH MANUAL OR AUTO
	CHECK BOX
	60/60/60 ELECTRICAL MANHOLE
	60/60/00 TELEPHONE MANHOLE

 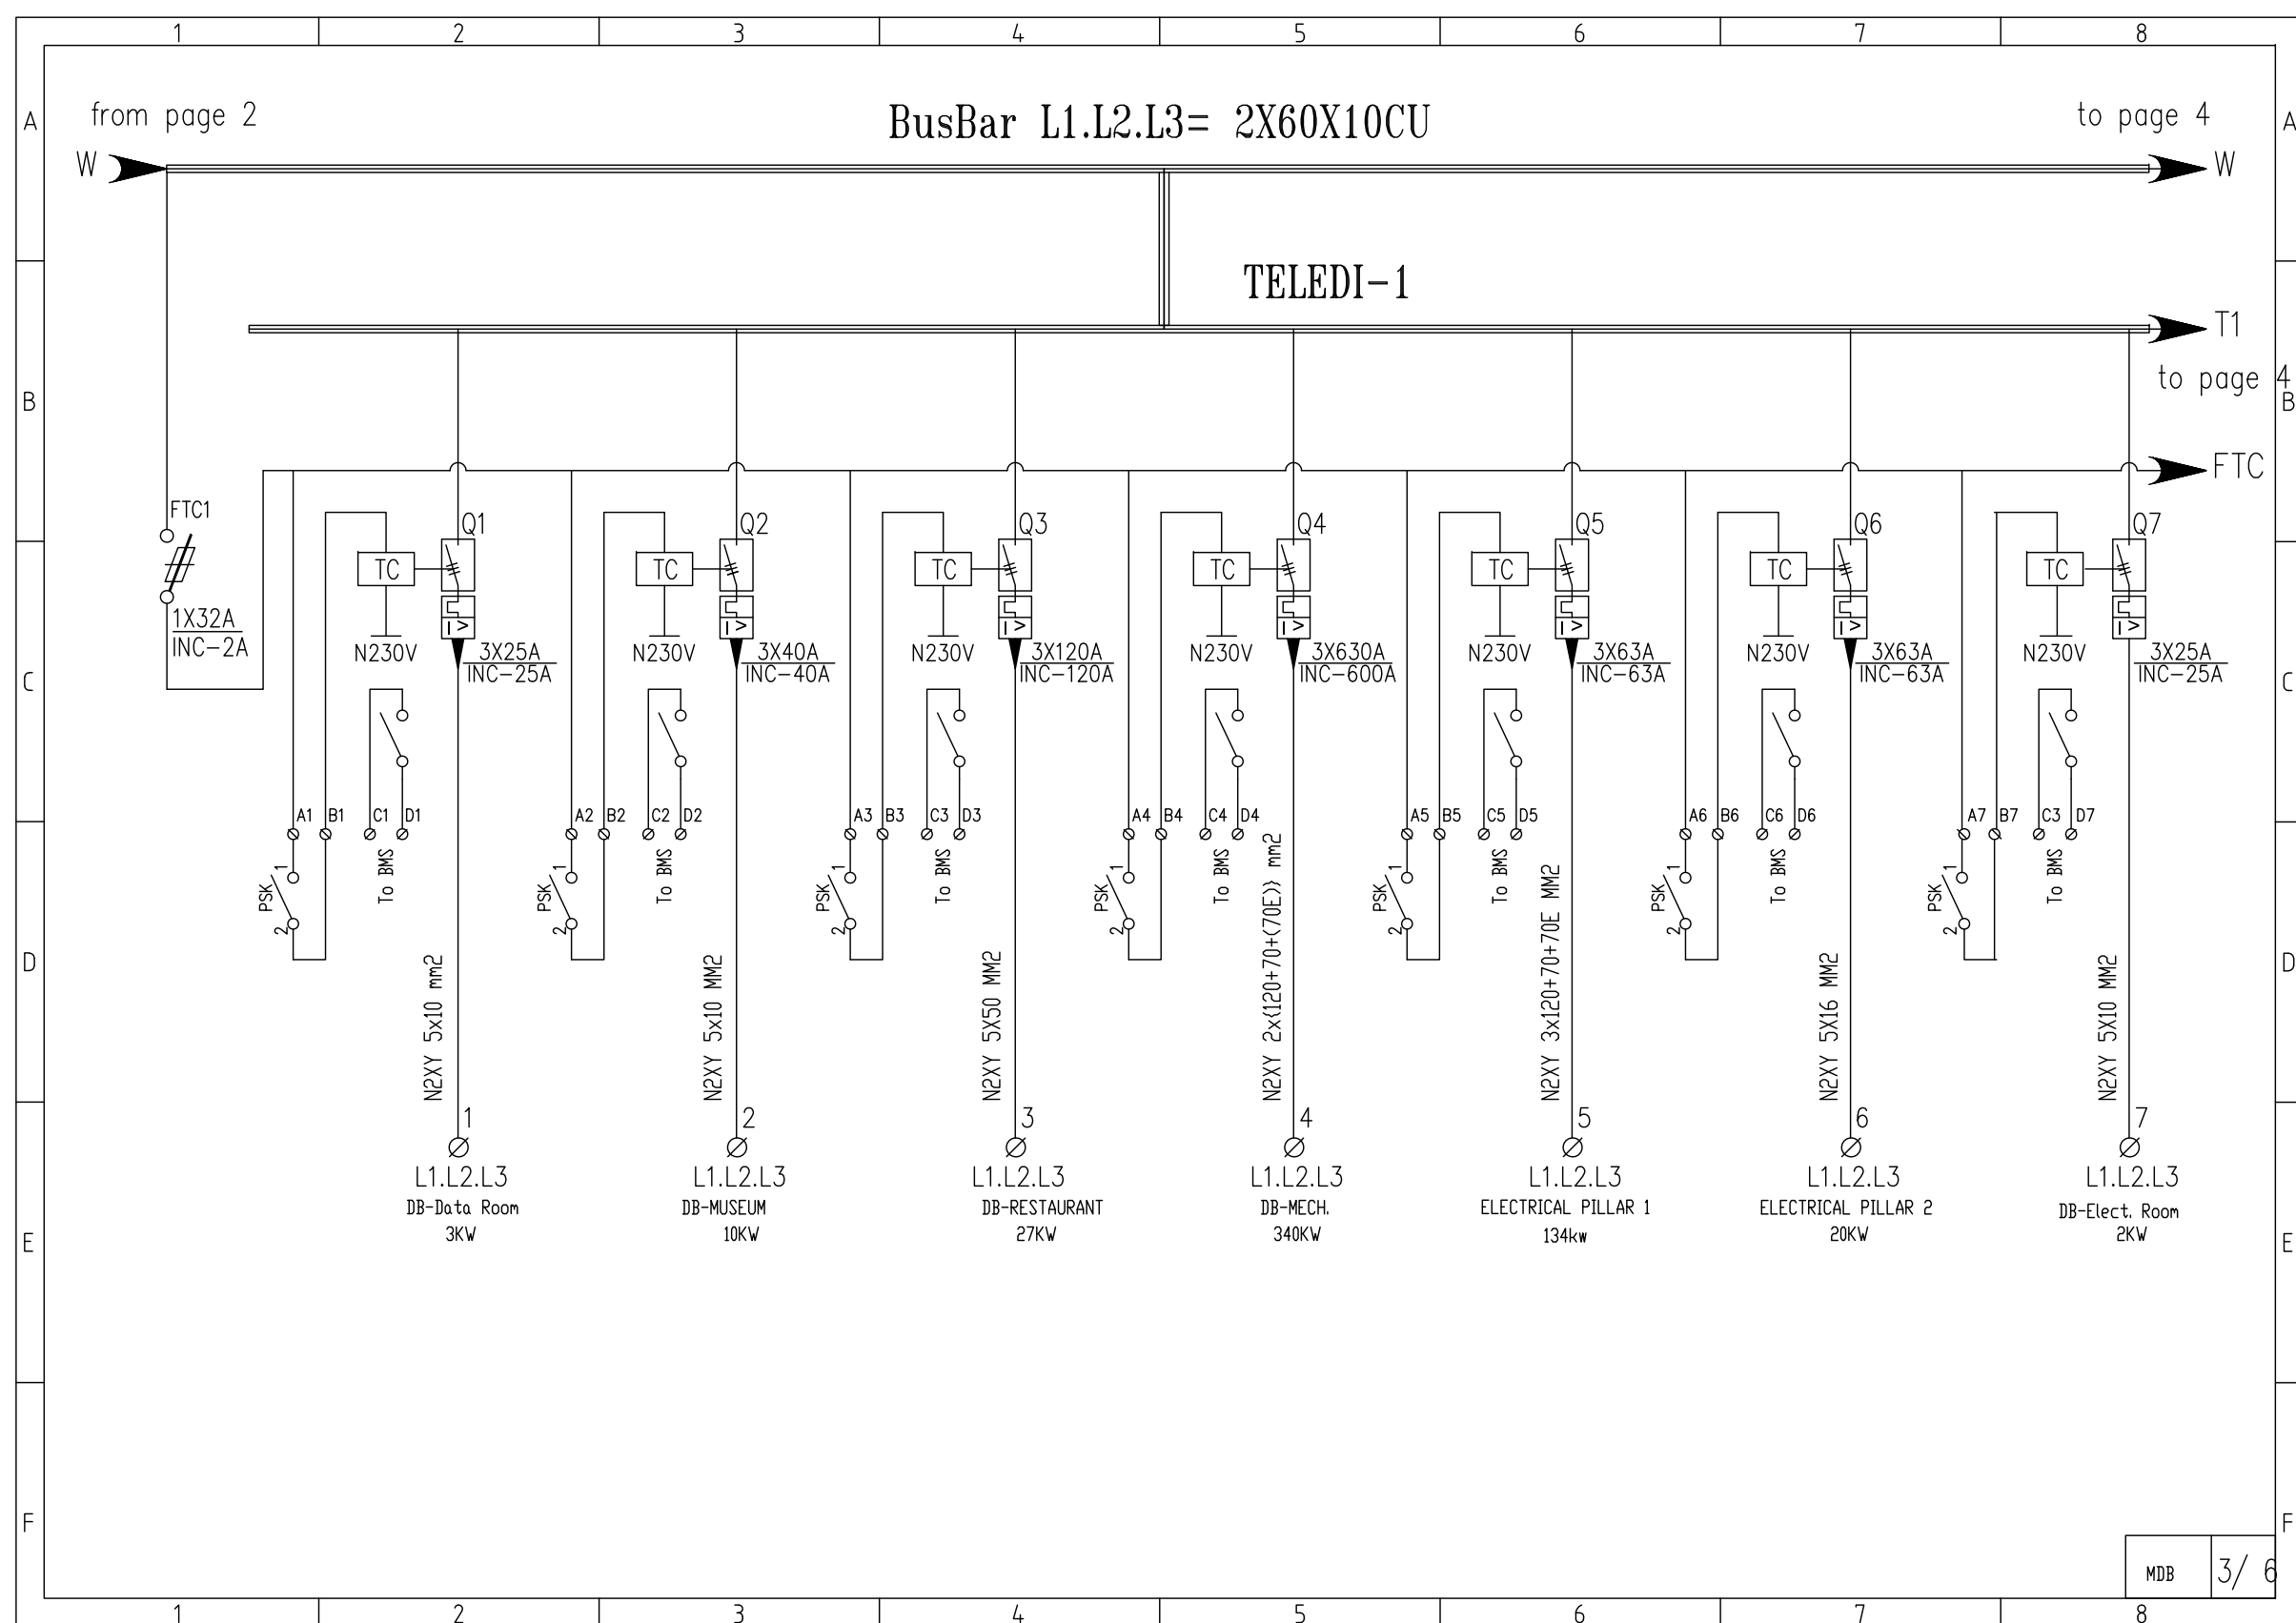

Securing Professional Services for the Architectural Restoration and Rehabilitation Designs, Archaeological Documentation and Orientation Training Including Tender Documents Preparation and Site Supervision for Conservation and Rehabilitation Works of Maqam Al-Nabi Musa in Jericho Governorate

Support to Development of Cultural Tourism






-Elite Mechanical Consultants

MDE

EDITION

SHE
NO

SYMBOL	DESCRIPTION
	THREE/SINGLE PHASE
	MAIN ELECTRIC BOARD L.V. SIDE
	METAL ELECTRIC BOARD WITH LOW VOLTAGE SIDE
	DISTRIBUTION BOARD
	GENERATOR
	STEP RELAY
	MOTORIZED AIR CIRCUIT BREAKER WITH TRIP RATING
	CONTACTOR
	INDICATOR LAMPS WITH PUSH BUTTON
	GENERAL MULTIMETER
	AMMETER/VOLTMETER
	TRANSFORMER
	THREE/SINGLE PHASE FUSE
	THREE/SINGLE PHASE EARTH LEAKAGE RELAY
	THREE PHASE KWHM
	SINGLE PHASE KWHM
	4-POLE CHANGE OVER SWITCH MANUAL OR AUTO
	CHECK BOX
	60°600MM ELECTRICAL MANHOLE
	60°600MM TELEPHONE MANHOLE

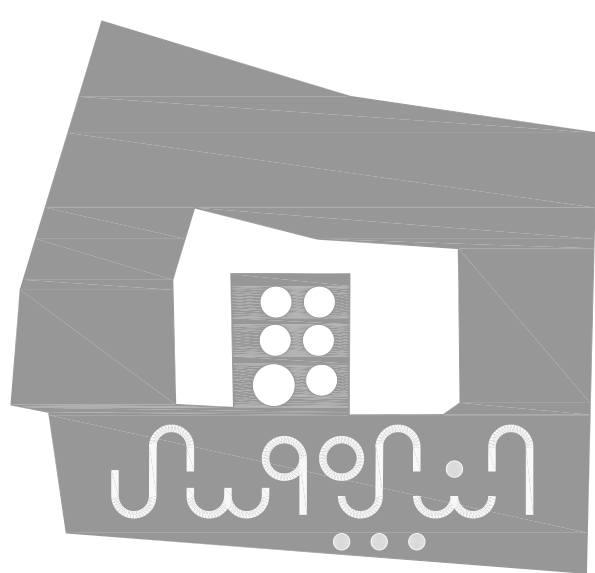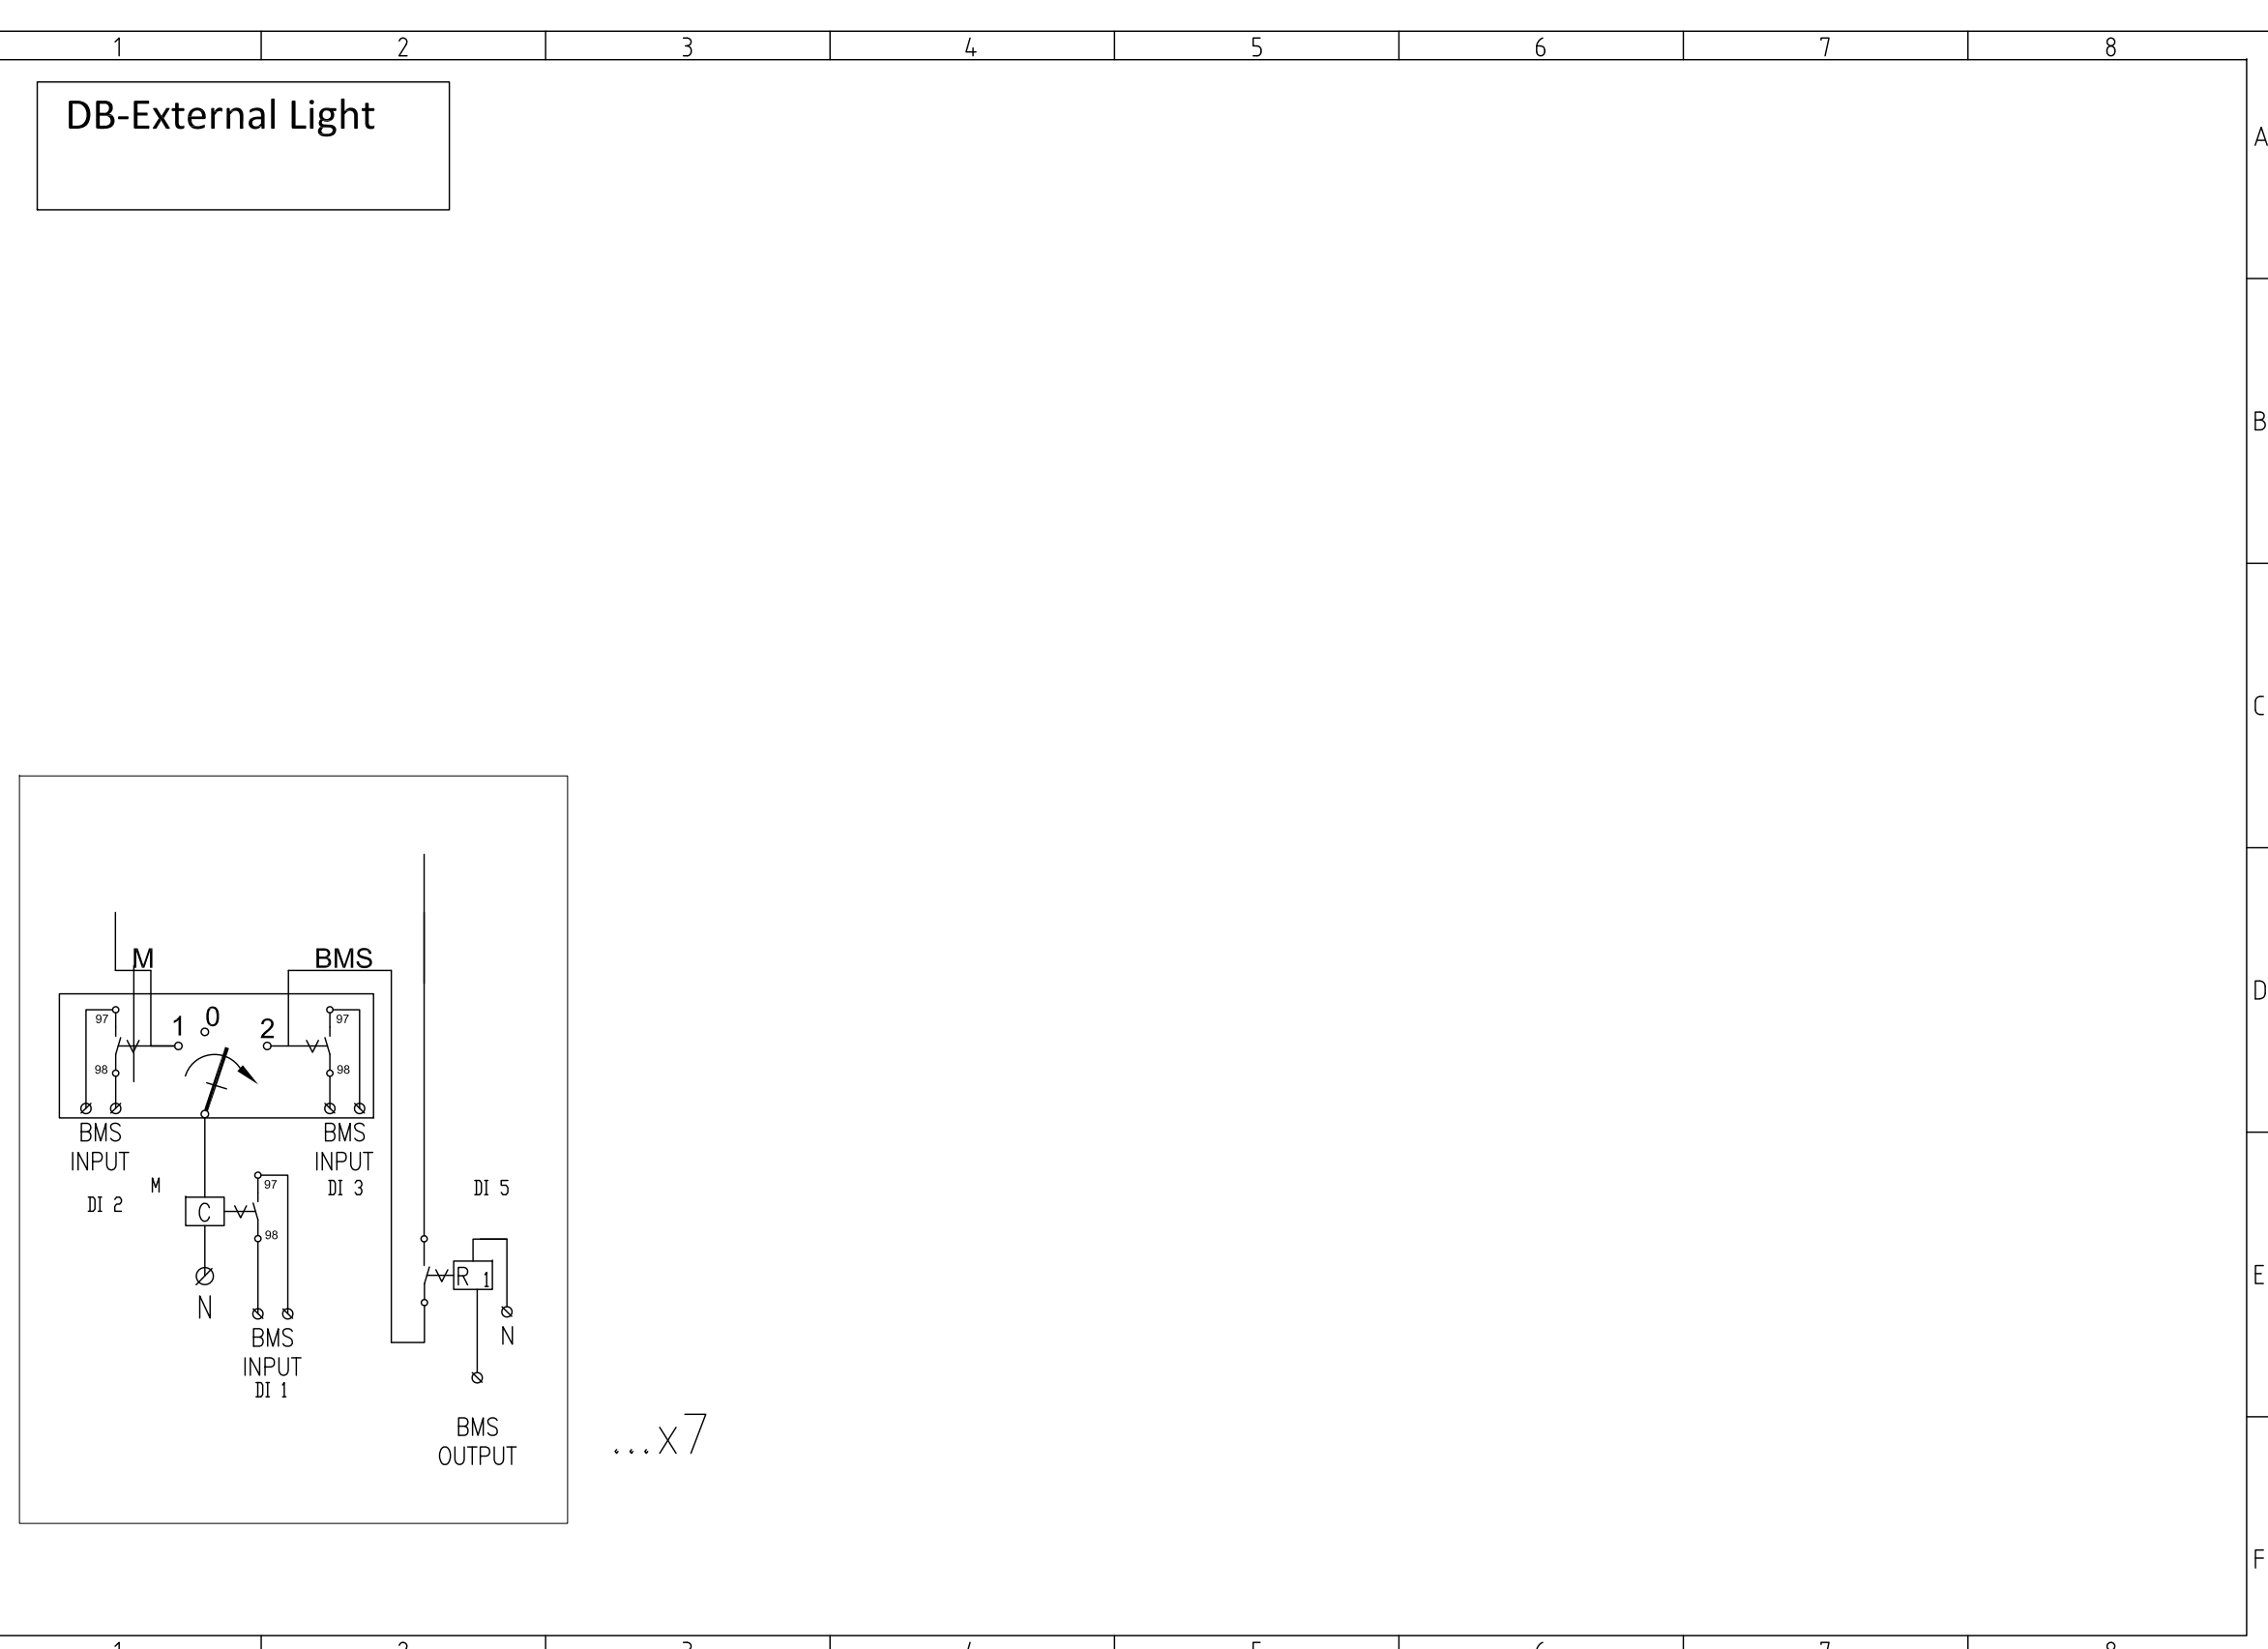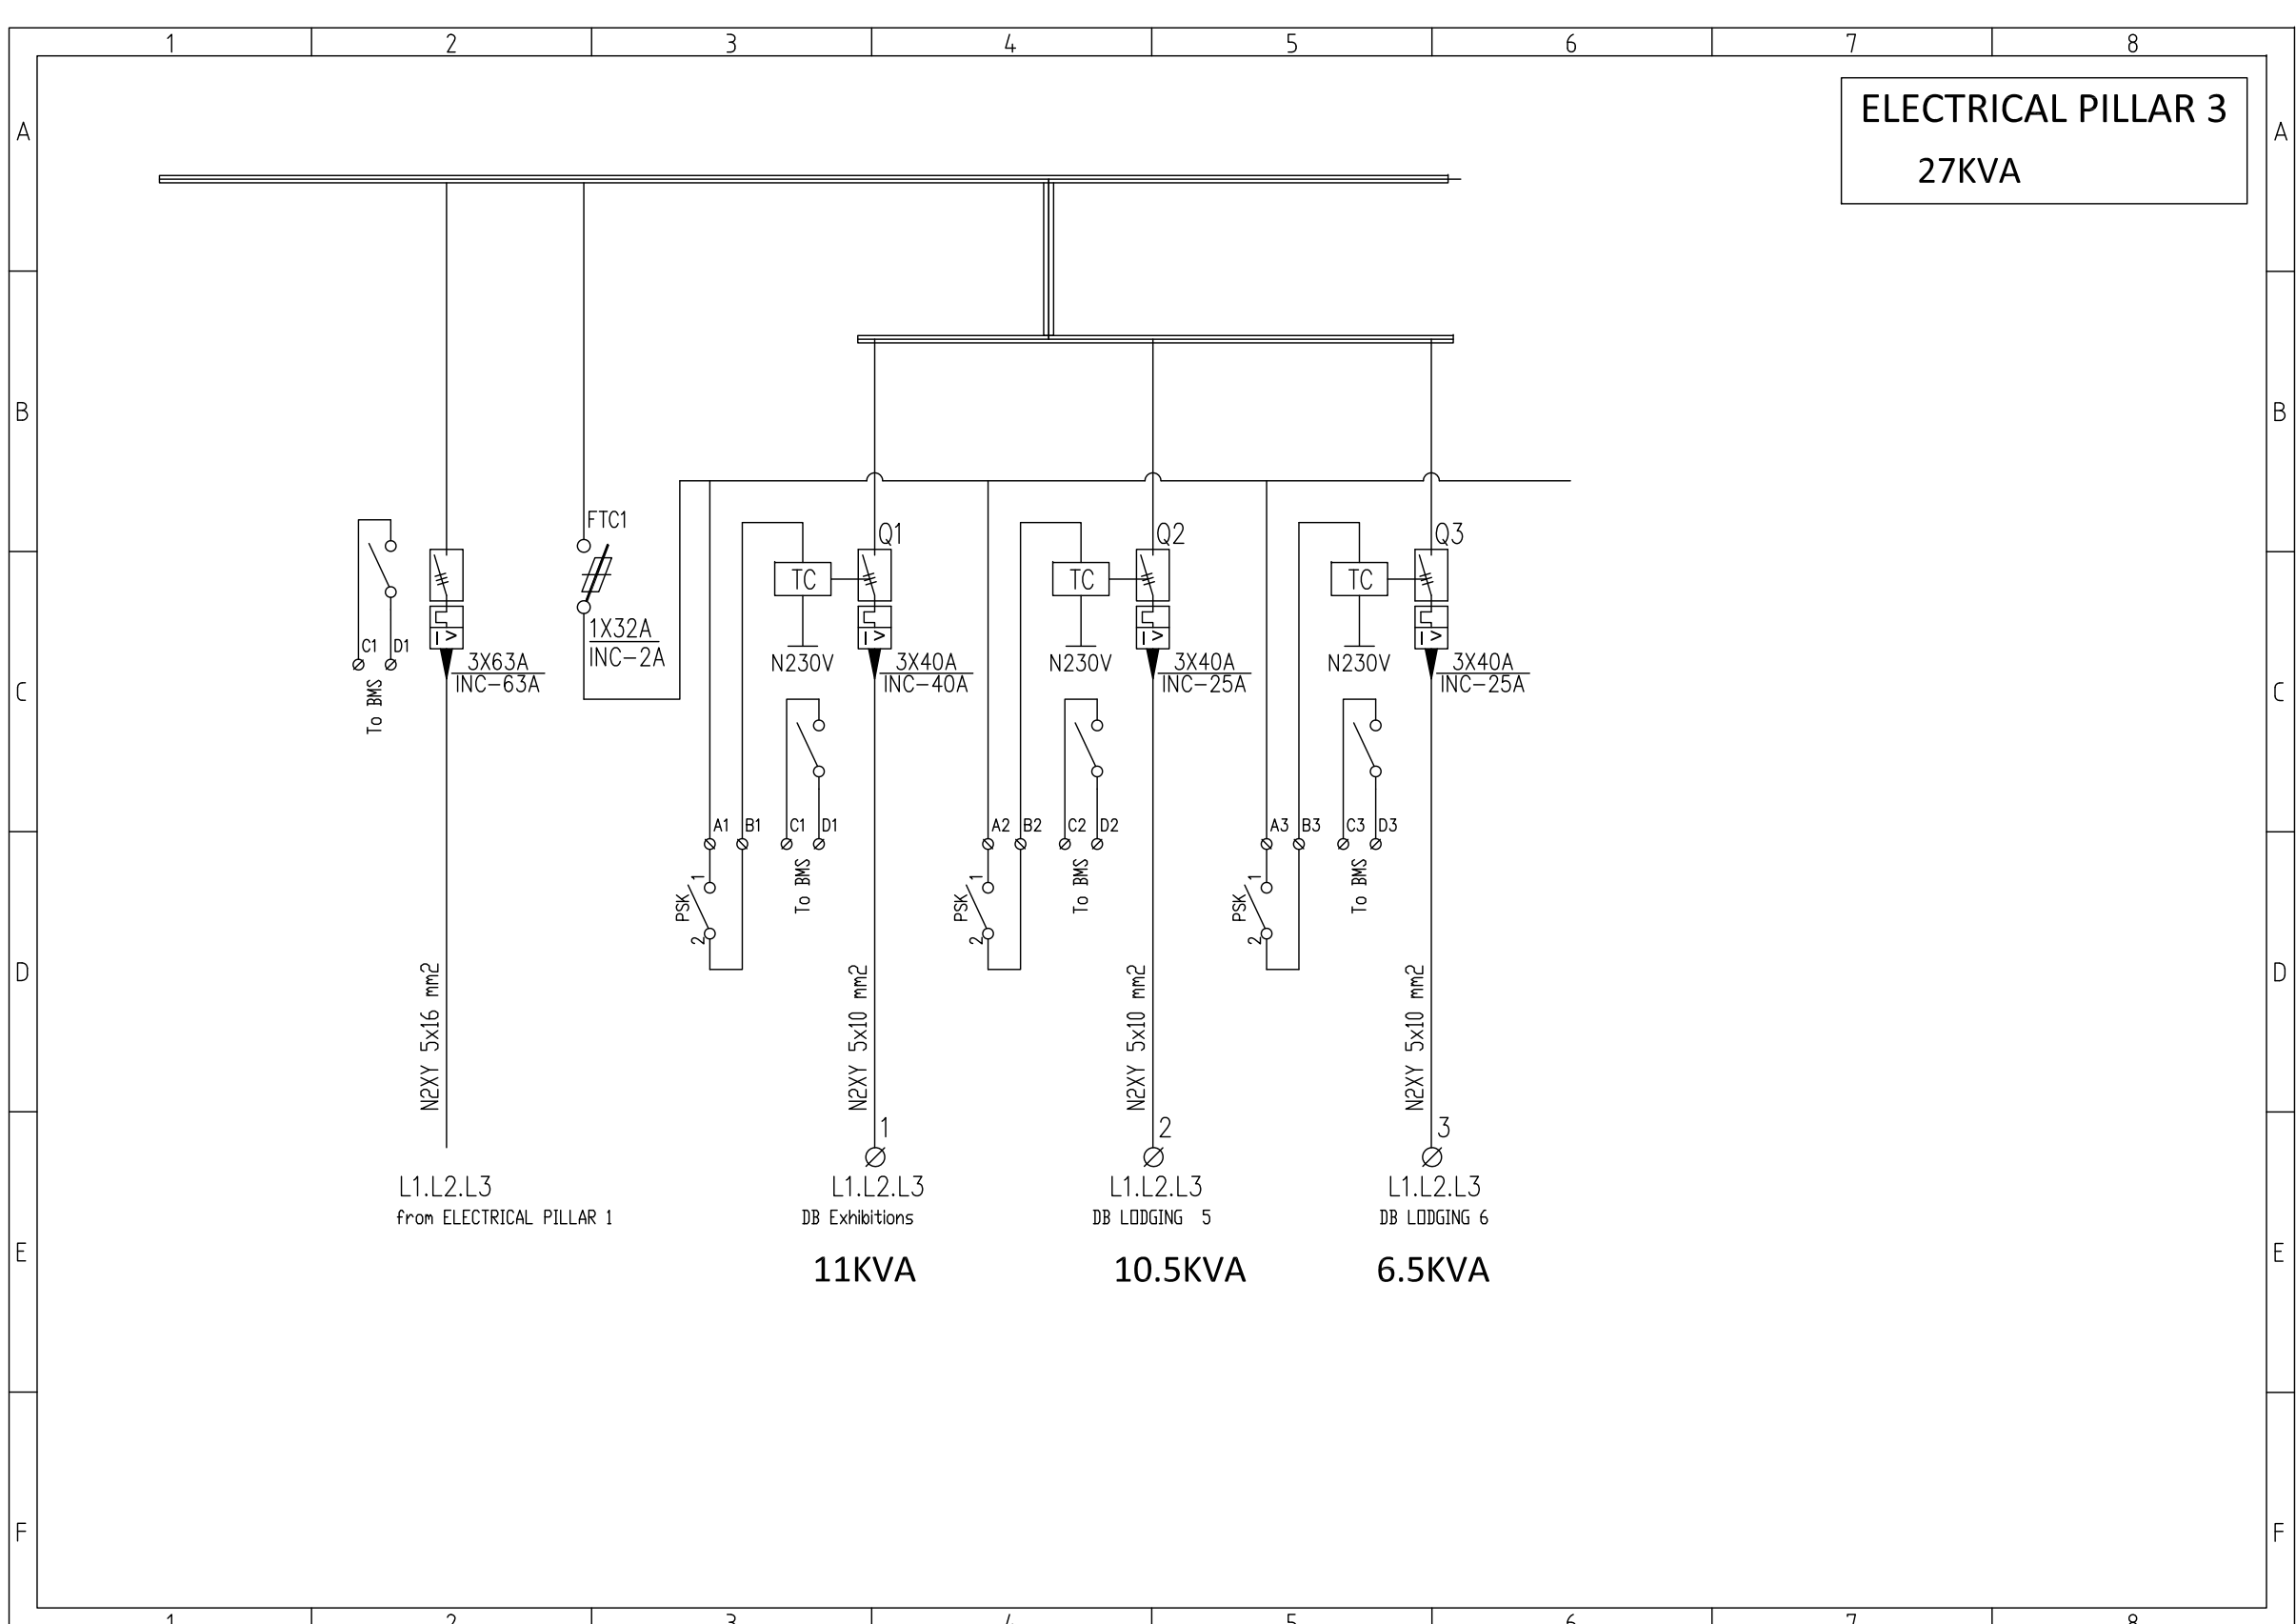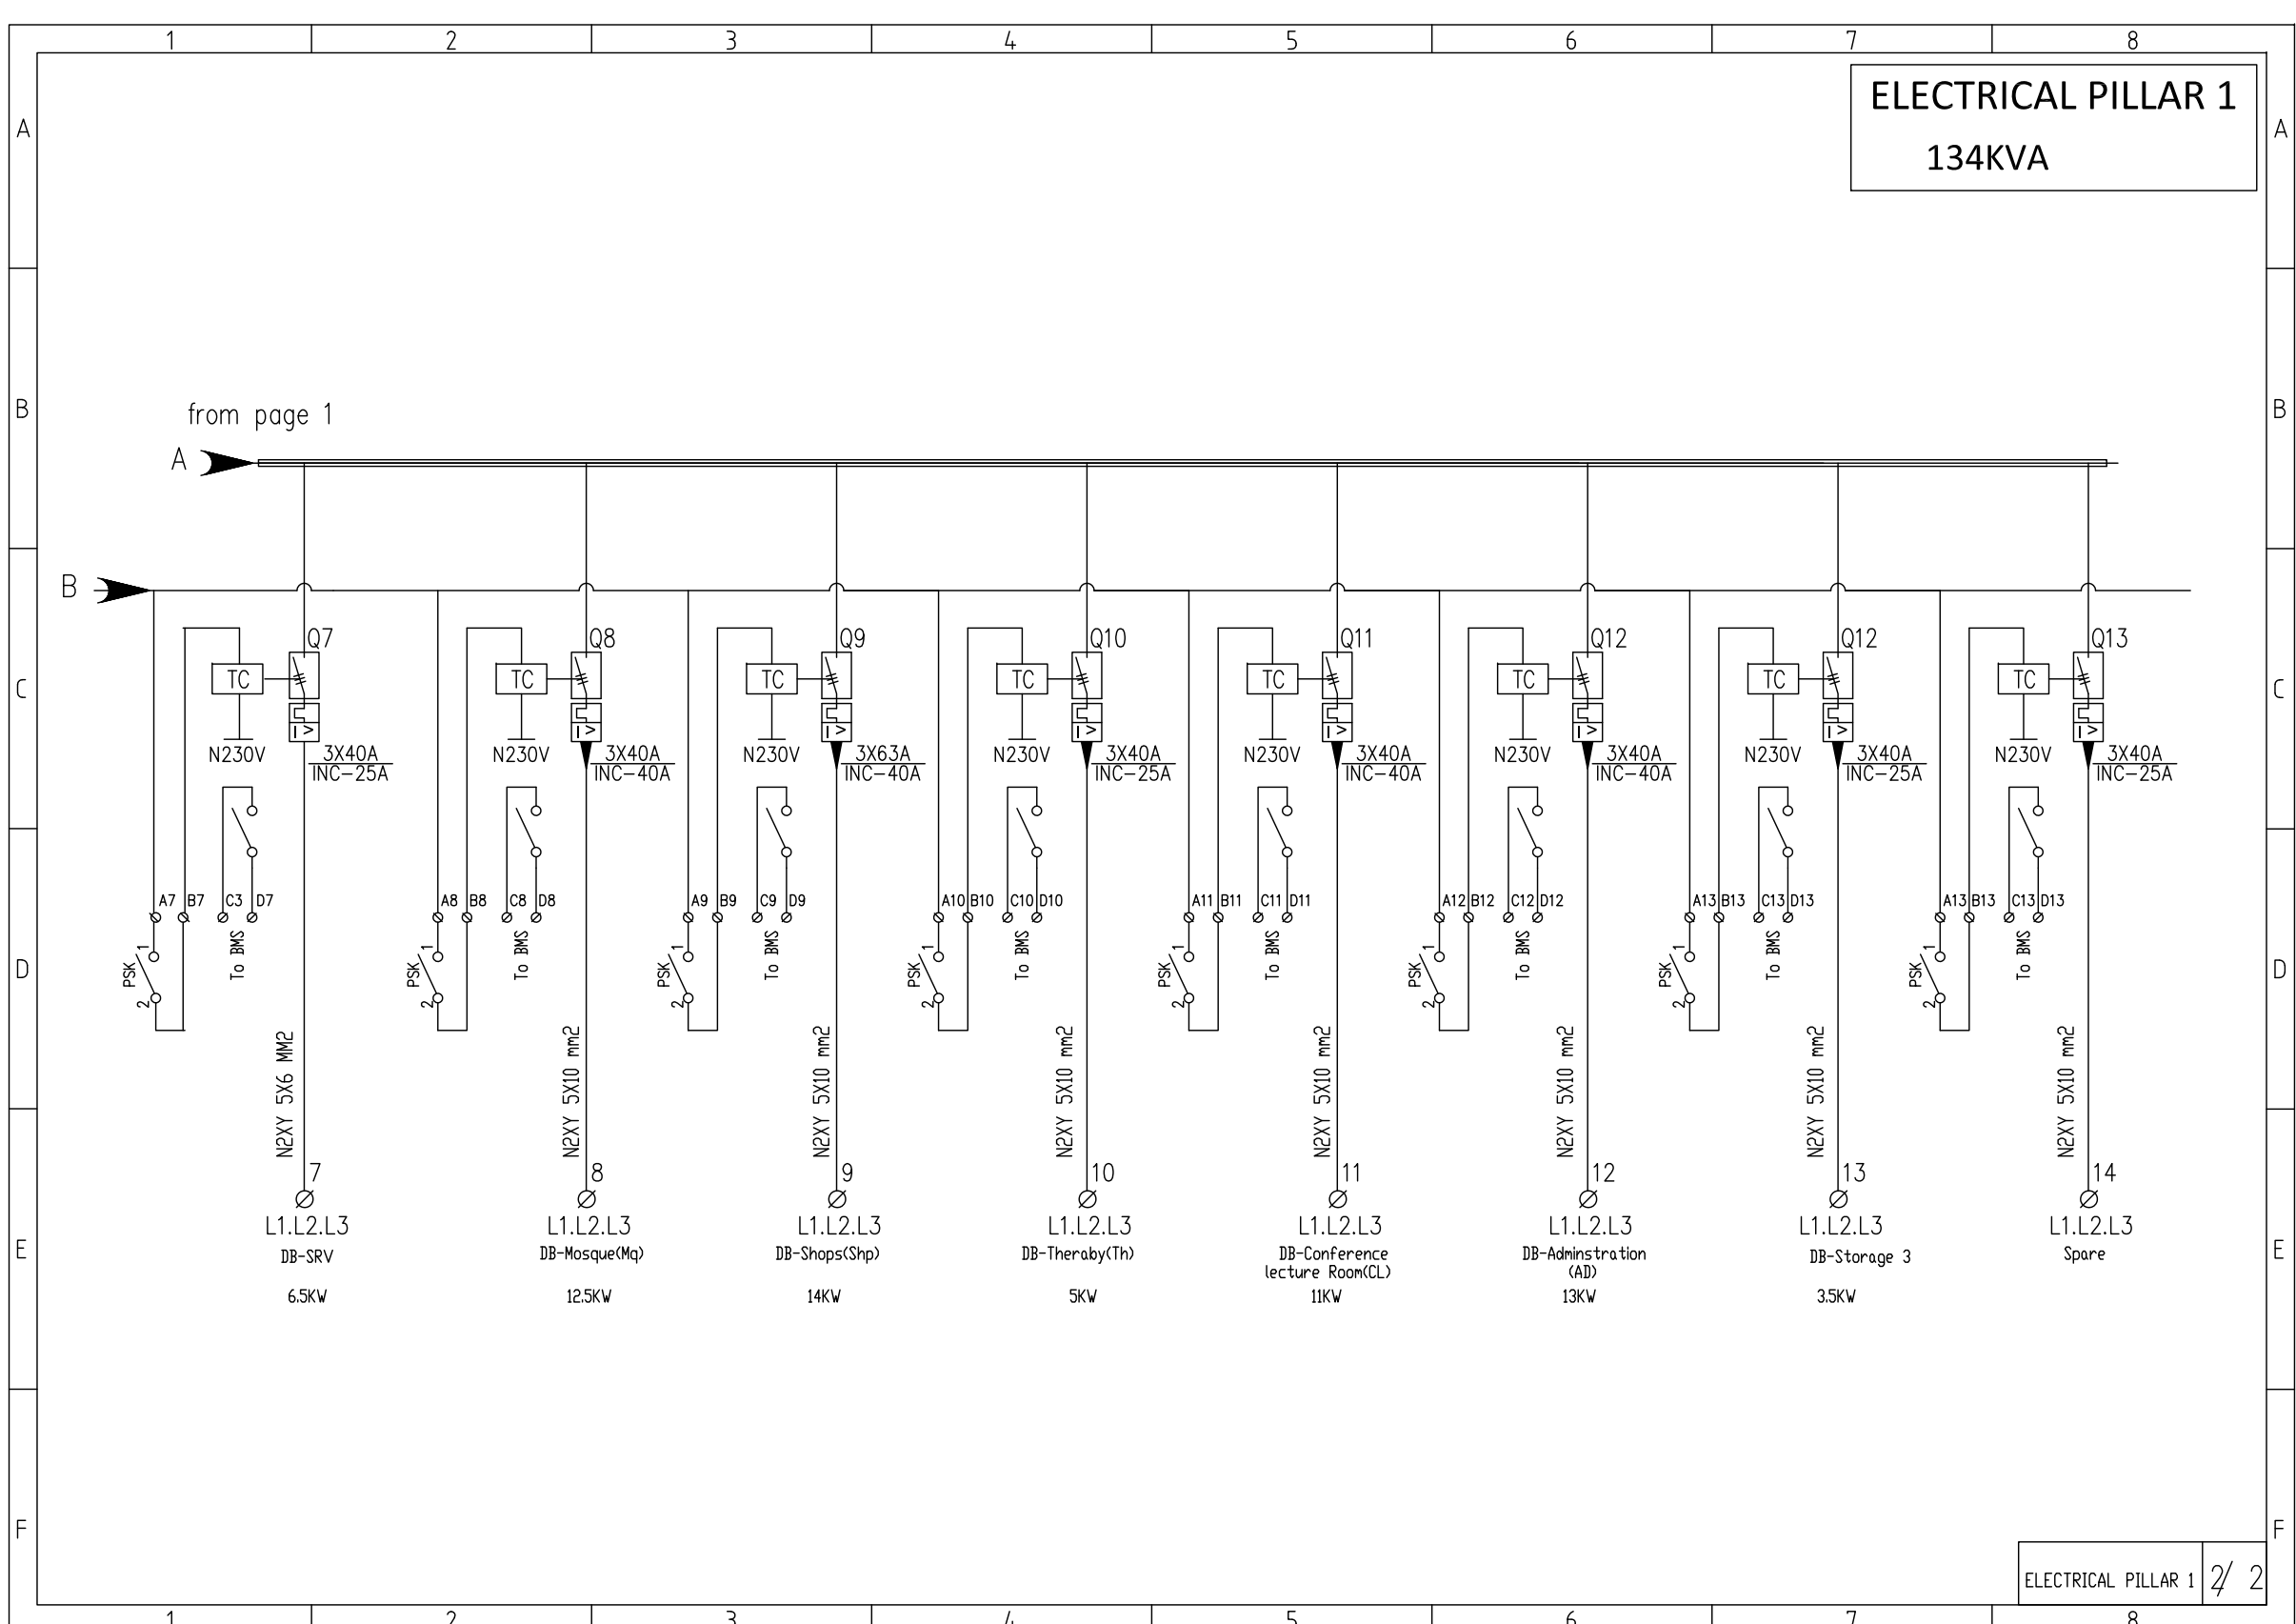

PROJECT

Securing Professional Services for the Architectural Restoration and Rehabilitation Designs, Archaeological Documentation and Orientation Training, Including Tender Documents Preparation and Site Supervision for Conservation and Rehabilitation Works of Maqam Al-Nabi Musa in Jericho Governorate

Support to Development of Cultural Tourism

DESIGN WORKS:



ELECTRICAL WORKS:

-Eng .Midhat AlSharif

MECHANICAL WORKS:

-Elite Mechanical Consultants

SHEET NAME:

Electrical Pillars
1, 2 & 3
DB-External Light


SCALE:	EDITION
--------	---------

☐ For Review☐ For Approval☒ For Tender☐ For Construction☐ For Consideration

DATE: July-2010



SYMBOL	DESCRIPTION
	THREE/SINGLE PHASE
	MAIN ELECTRIC BOARD L.V. SIDE
	METAL ELECTRIC BOARD WITH LOW VOLTAGE SIDE
	DISTRIBUTION BOARD
	GENERATOR
	STEP RELAY
	MOTORIZED AIR CIRCUIT BREAKER WITH TRIP RATING
	CONTACTOR
	INDICATOR LAMPS WITH PUSH BUTTON
	GENERAL MULTIMETER
	AMETER/VOLTMETER
	TRANSFORMER
	THREE/SINGLE PHASE FUSE
	THREE/SINGLE PHASE EARTH LEAKAGE RELAY
	THREE PHASE KWHM
	SINGLE PHASE KWHM
	4-POLE CHANGE OVER SWITCH MANUAL OR AUTO
	CHECK BOX
	60°60CM ELECTRICAL MANHOLE
	60°60CM TELEPHONE MANHOLE

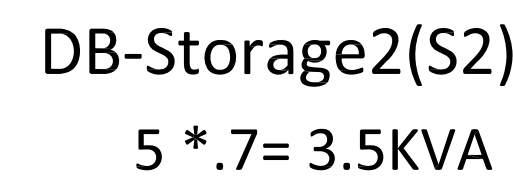

PROJECT:

Securing Professional Services for the Architectural Restoration and Rehabilitation Designs, Archaeological Documentation and Orientation Training, Including Tender Documents Preparation and Site Supervision for Conservation and Rehabilitation Works of Maqam Al-Nabi Musa in Jericho Governorate

Support to Development of Cultural Tourism

DESIGN WORKS:



ELECTRICAL WORKS:

-Eng .Midhat AlSharif

MECHANICAL WORKS:


-Elite Mechanical Consultants

SHEET NAME:


Storages Electrical Panel
DB-S1, DB-S2 & DB-S3

SCALE:	EDITION:
--------	----------

☐ For Review☐ For Approval☐ For Tender

DATE: July-2010






DATE: July-2010

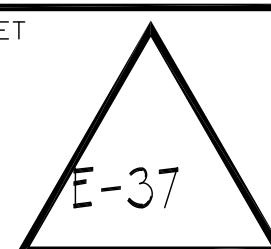

DATE: July-2010



Phone: 02 234 3696 | Fax: 02 234 3719 | Email: info@ide.no

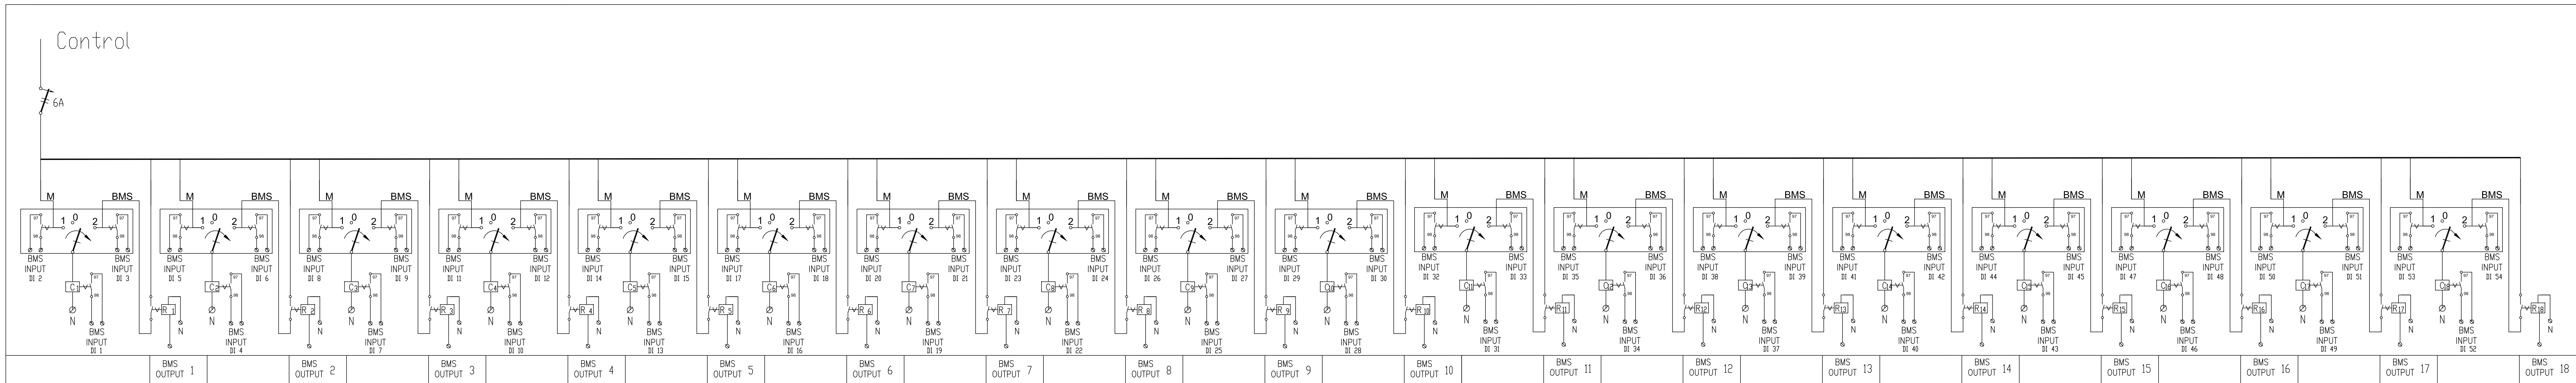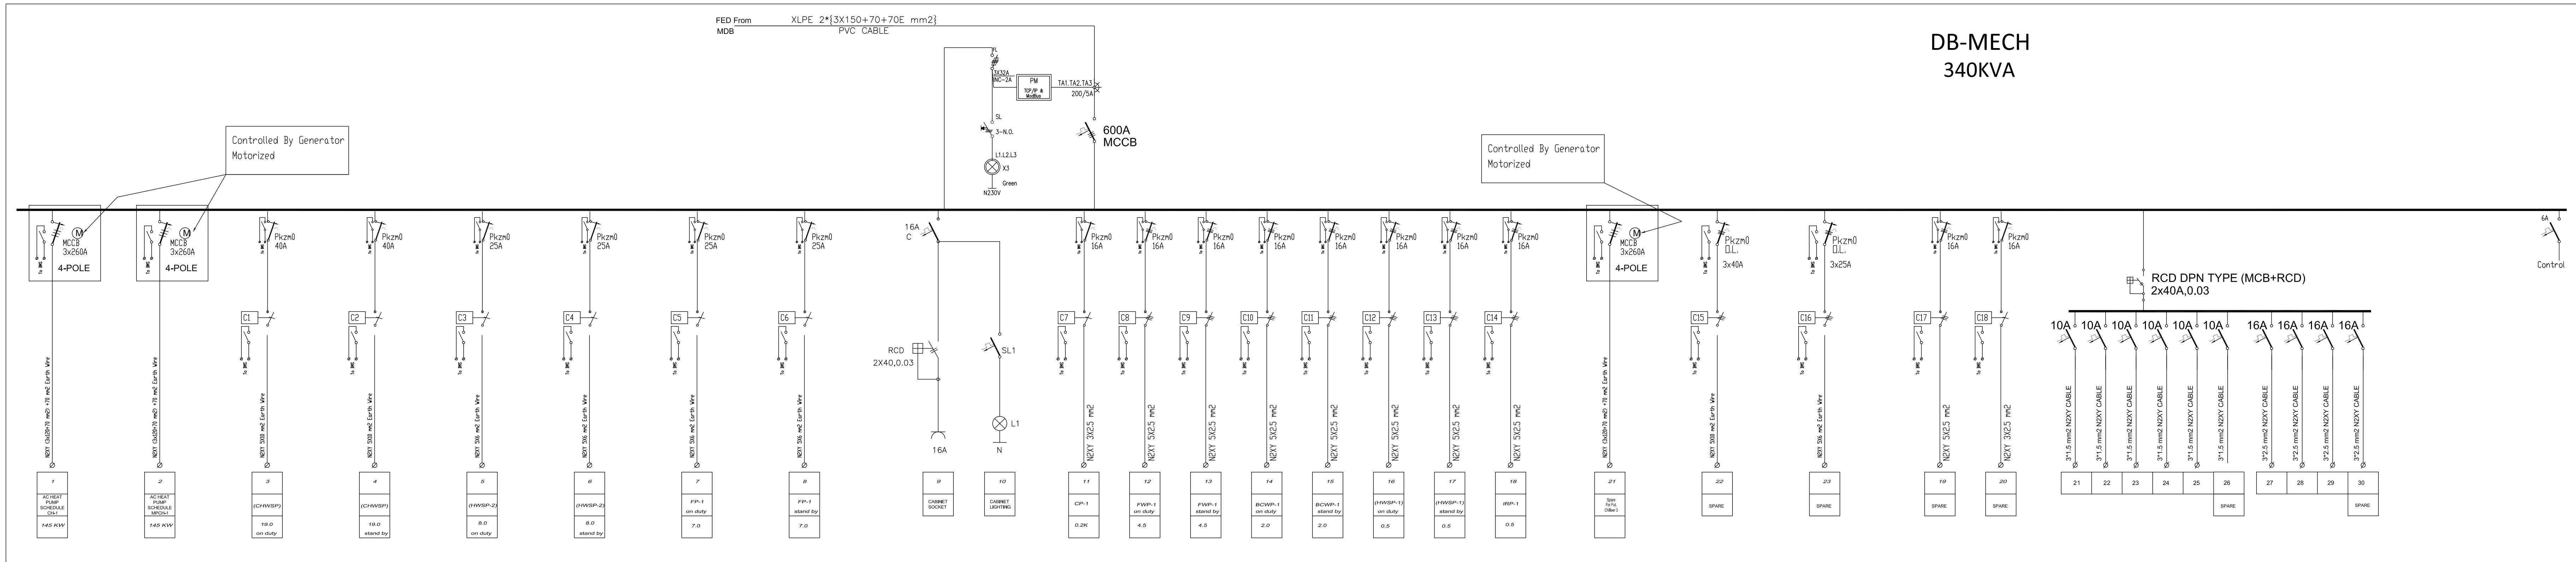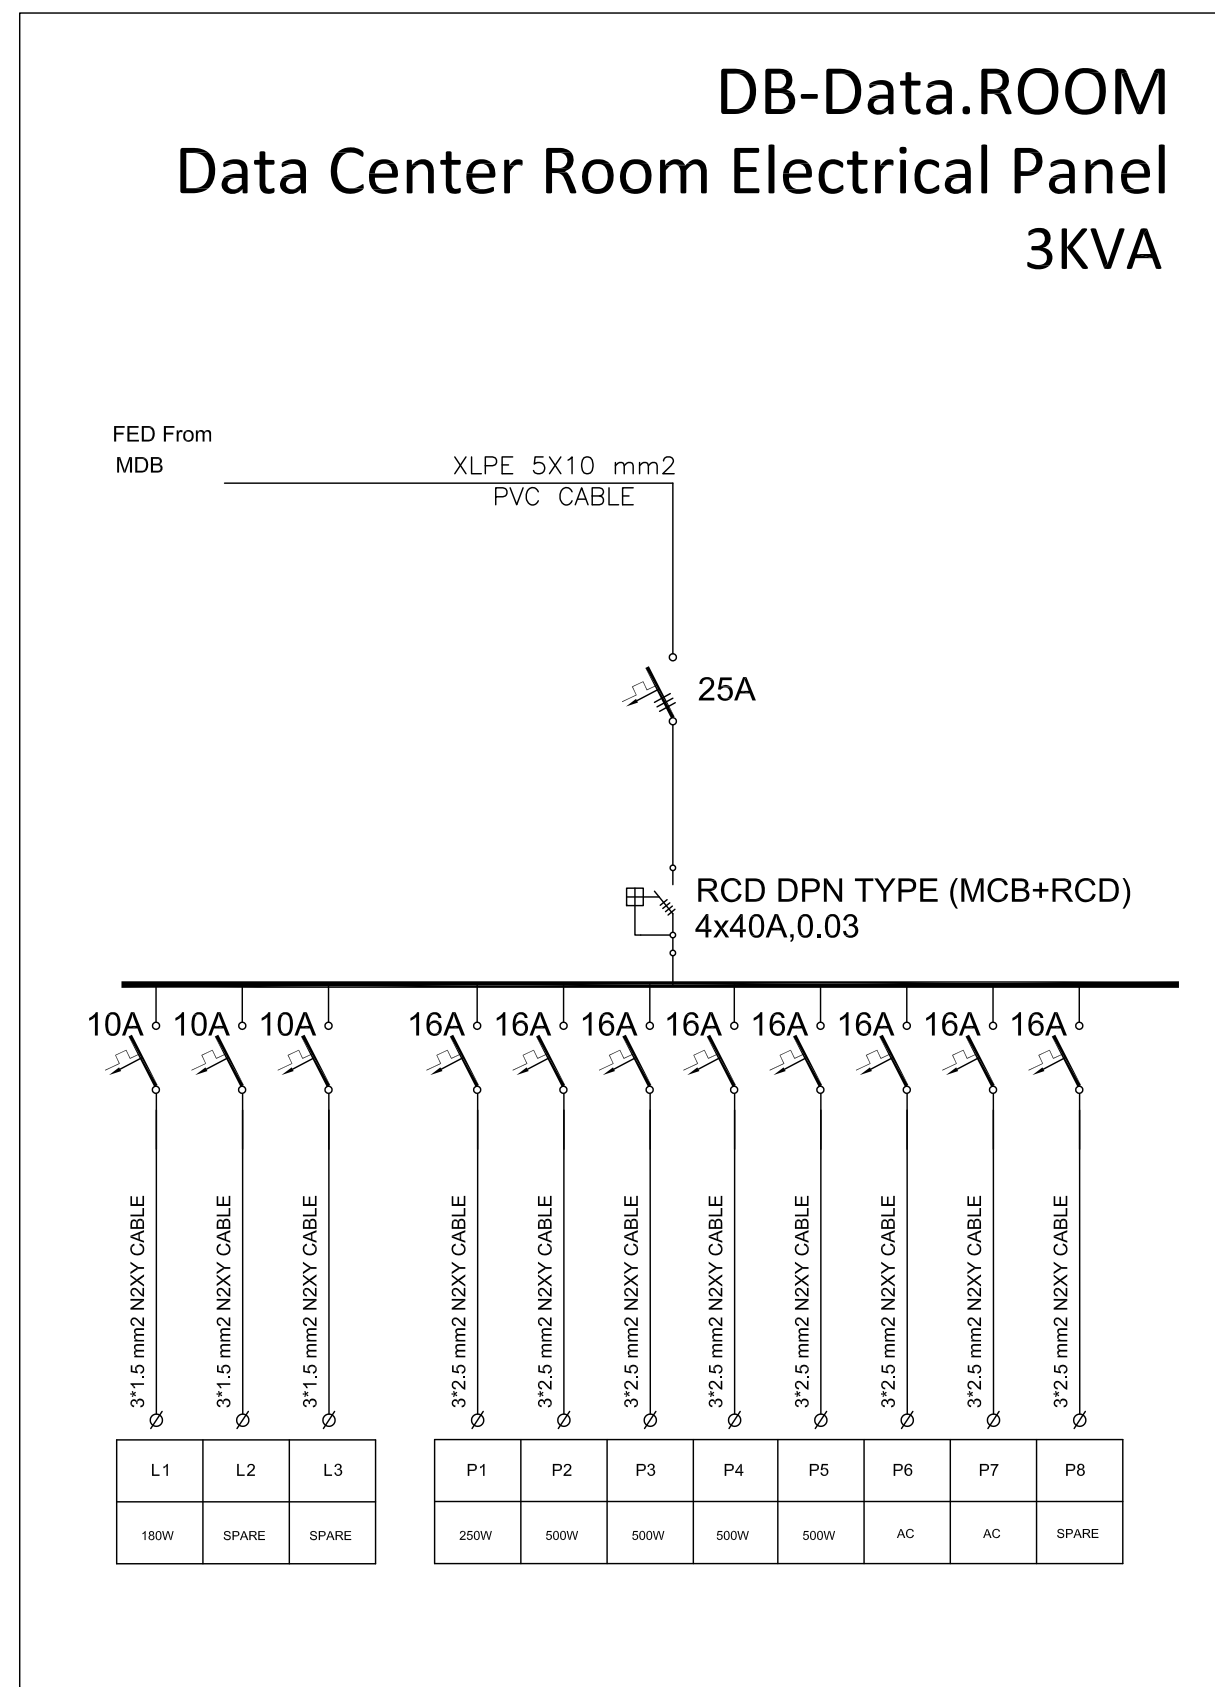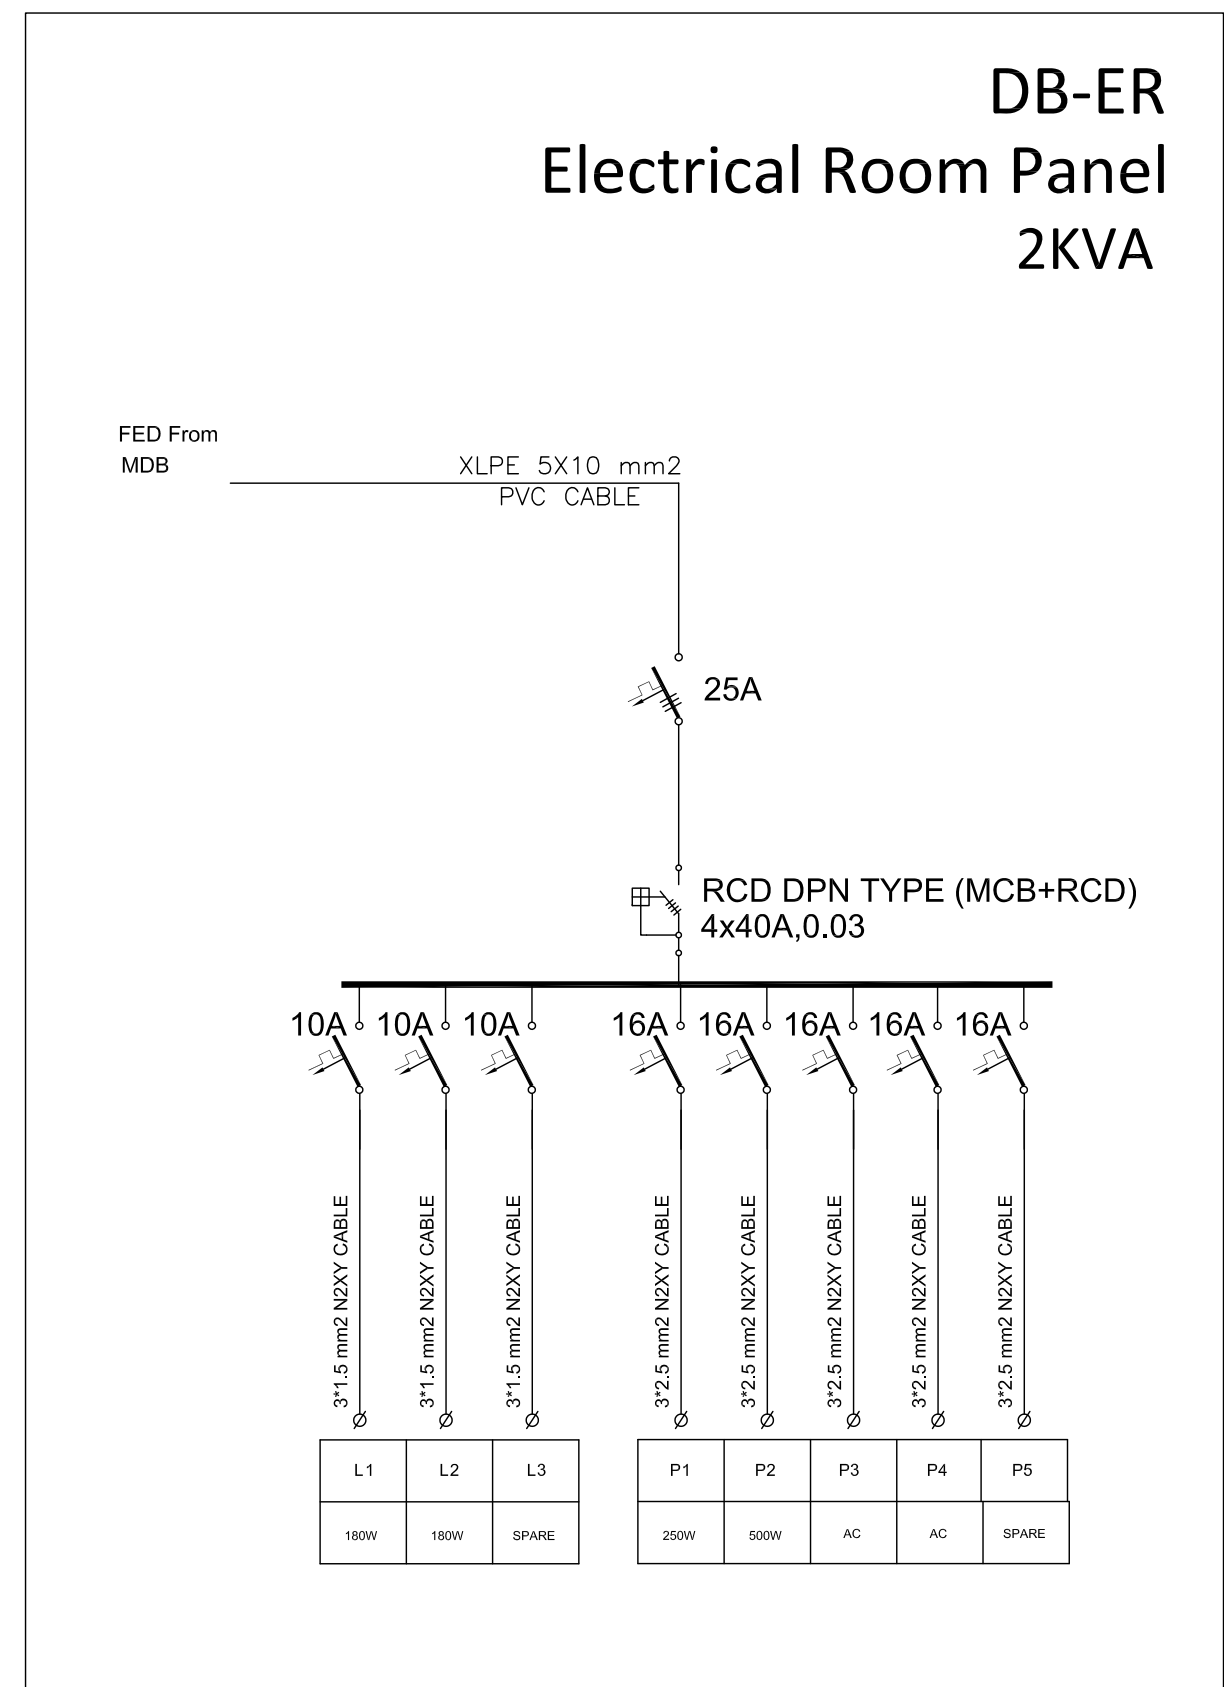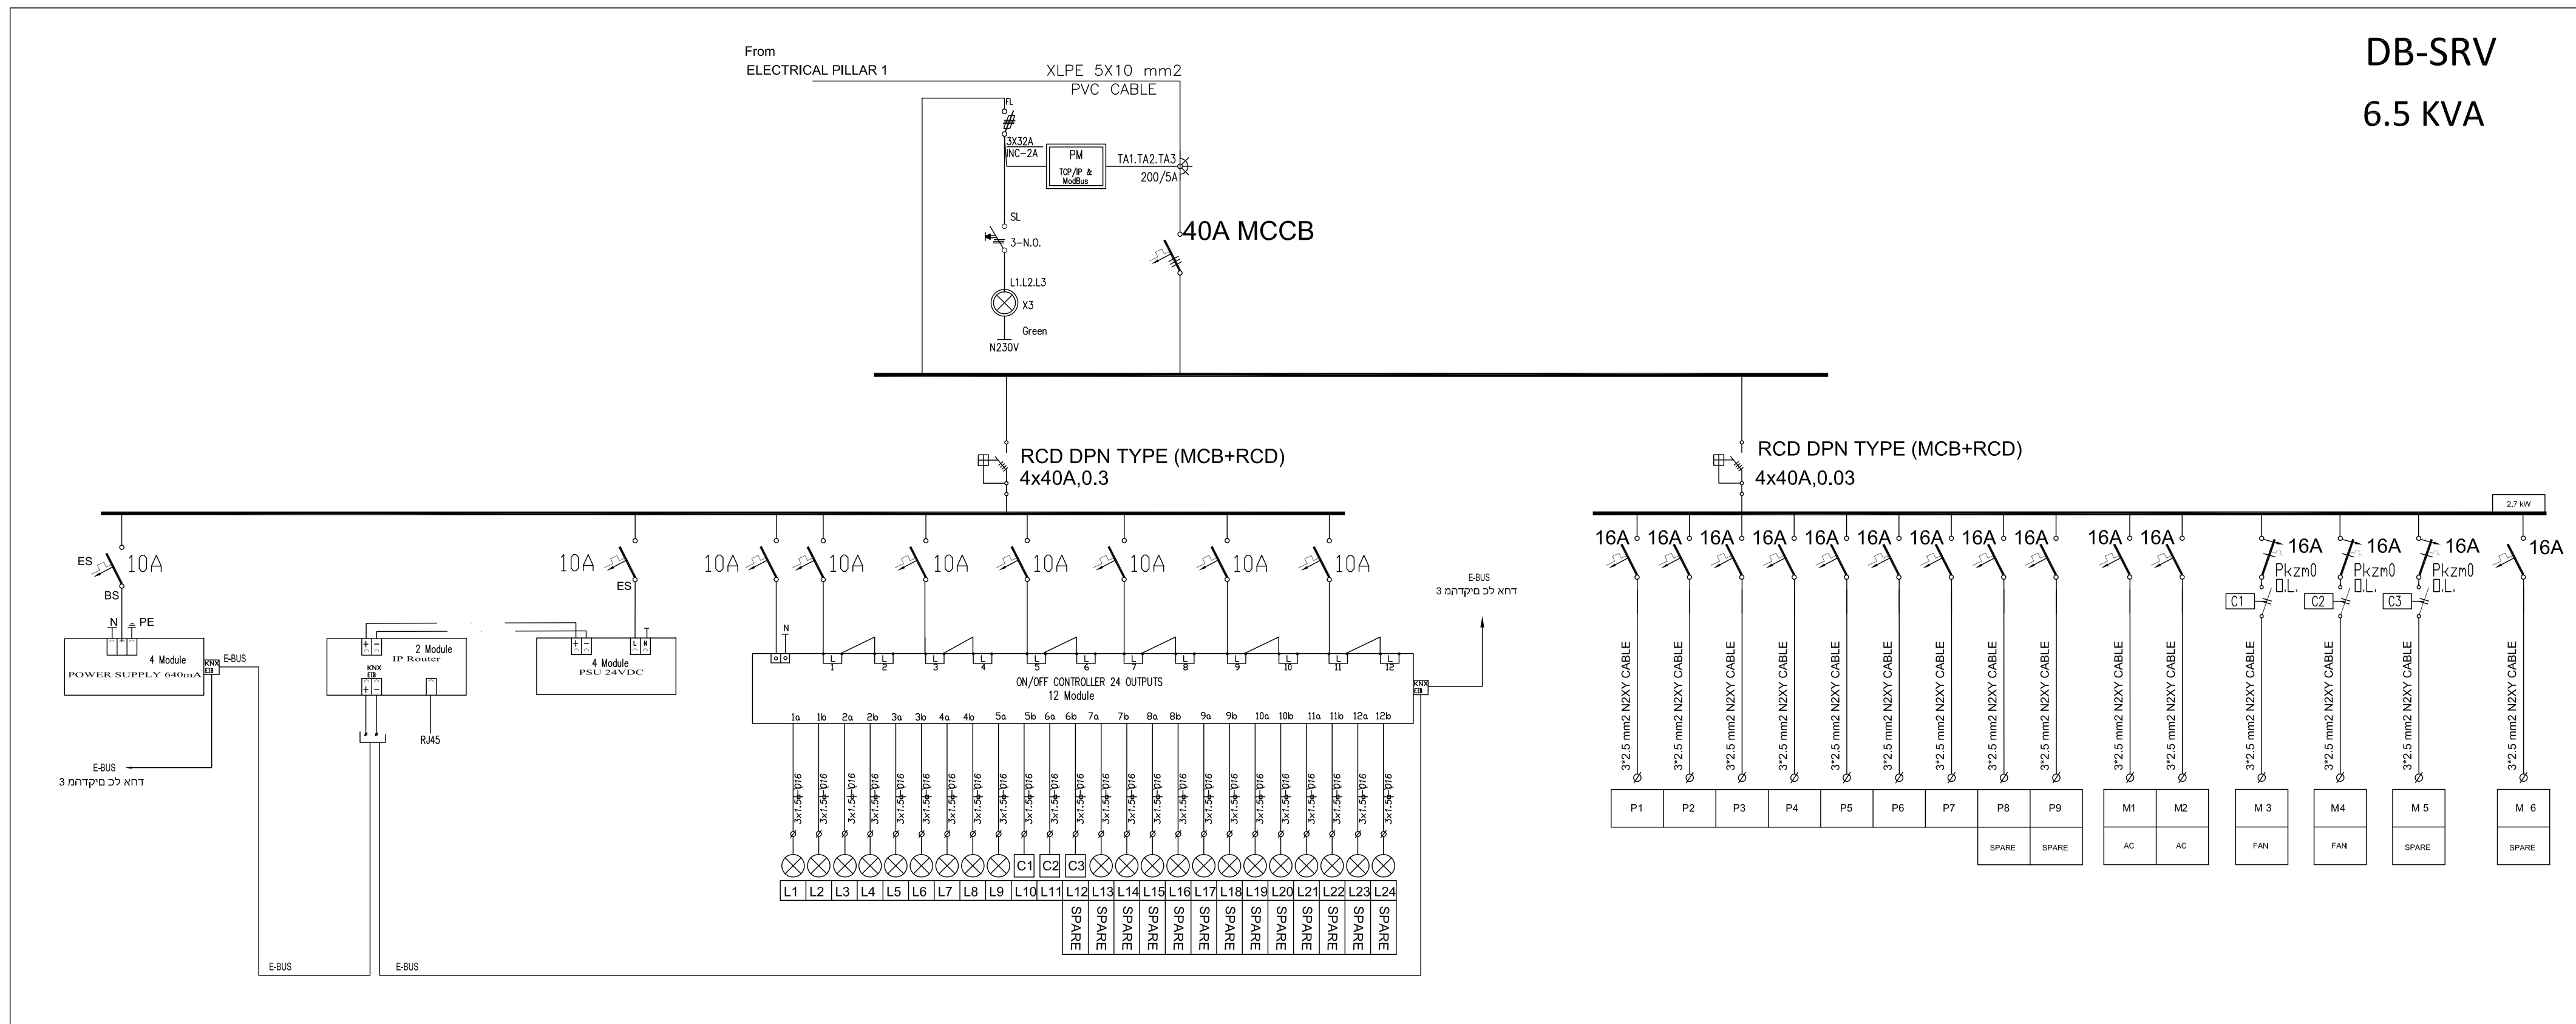

NOTES & LEGEND:

SYMBOL	DESCRIPTION
	THREE/SINGLE PHASE
	MAIN ELECTRIC BOARD LV. SIDE
	METAL ELECTRIC BOARD WITH LOW VOLTAGE SIDE
	DISTRIBUTION BOARD
	GENERATOR
	STEP RELAY
	MOTORIZED AIR CIRCUIT BREAKER WITH TRIP RATING
	CONTACTOR
	INDICATOR LAMPS WITH PUSH BUTTON
	GENERAL MULTIMETER
	AMETER/VOLTMETER
	TRANSFORMER
	THREE/SINGLE PHASE FUSE
	THREE/SINGLE PHASE EARTH LEAKAGE RELAY
	THREE PHASE KWHM
	SINGLE PHASE KWHM
	4-POLE CHANGE OVER SWITCH MANUAL OR AUTO
	CHECK BOX
	60*60CM ELECTRICAL MANHOLE
	60*60CM TELEPHONE MANHOLE

For Review
For Approval
For Tender
For Construction



DATE: July-2016

SHEET NO. E-38

Jerusalem Design Center
Architects, Engineers & Consultants

Phone: 02 234 3696 | Fax: 02 234 3710 | Email: info@jdc.jo

SYMBOL	DESCRIPTION
	THREE/SINGLE PHASE
	MAIN ELECTRIC BOARD L.V. SIDE
	METAL ELECTRIC BOARD WITH LOW VOLTAGE SIDE
	DISTRIBUTION BOARD
	GENERATOR
	STEP RELAY
	MOTORIZED AIR CIRCUIT BREAKER WITH TRIP RATING
	CONTACTOR
	INDICATOR LAMPS WITH PUSH BUTTON
	GENERAL MULTIMETER
	AMMETER/VOLTMETER
	TRANSFORMER
	THREE/SINGLE PHASE FUSE
	THREE/SINGLE PHASE EARTH LEAKAGE RELAY
	THREE PHASE KWHM
	SINGLE PHASE KWHM
	4-POLE CHANGE OVER SWITCH MANUAL OR AUTO
	CHECK BOX
	60°60CM ELECTRICAL MANHOLE
	60°60CM TELEPHONE MANHOLE

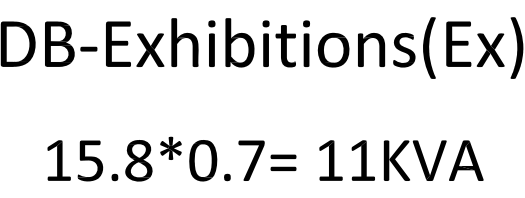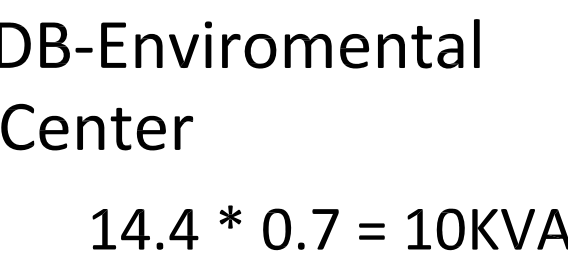

Securing Professional Services for the Architectural Restoration and Rehabilitation Designs, Archaeological Documentation and Orientation Training, Including Tender Documents Preparation and Site Supervision for Conservation and Rehabilitation Works of Maqam Al-Nabi Musa in Jericho Governorate

DESIGN WORKS:

 -Jerusalem Design Center

ELECTRICAL WORKS:

MIDHAT AL-SHARIF
Electrical Engineer
Consulting Engineer
for Electrical Works

-Eng .Midhat AlSharif

MECHANICAL WORKS:

 -Elite Mechanical Consultants

SHEET NAME:
DB-Enviromental
DB-Exhibitions

SCALE:	EDITION:
--------	----------

- ☐ For Review
☐ For Approval
☒ For Tender
☐ For Construction

DATE: July-2016

