



Ramadi IDP Shelter Compound

Iraq- Al Anbar

350 Unit

Date: 02-09-2016



Architectural Drawings




Ramadi IDP Shelter Compound
General View




Ramadi IDP Shelter Compound
General View



Ramadi IDP Shelter Compound
General View

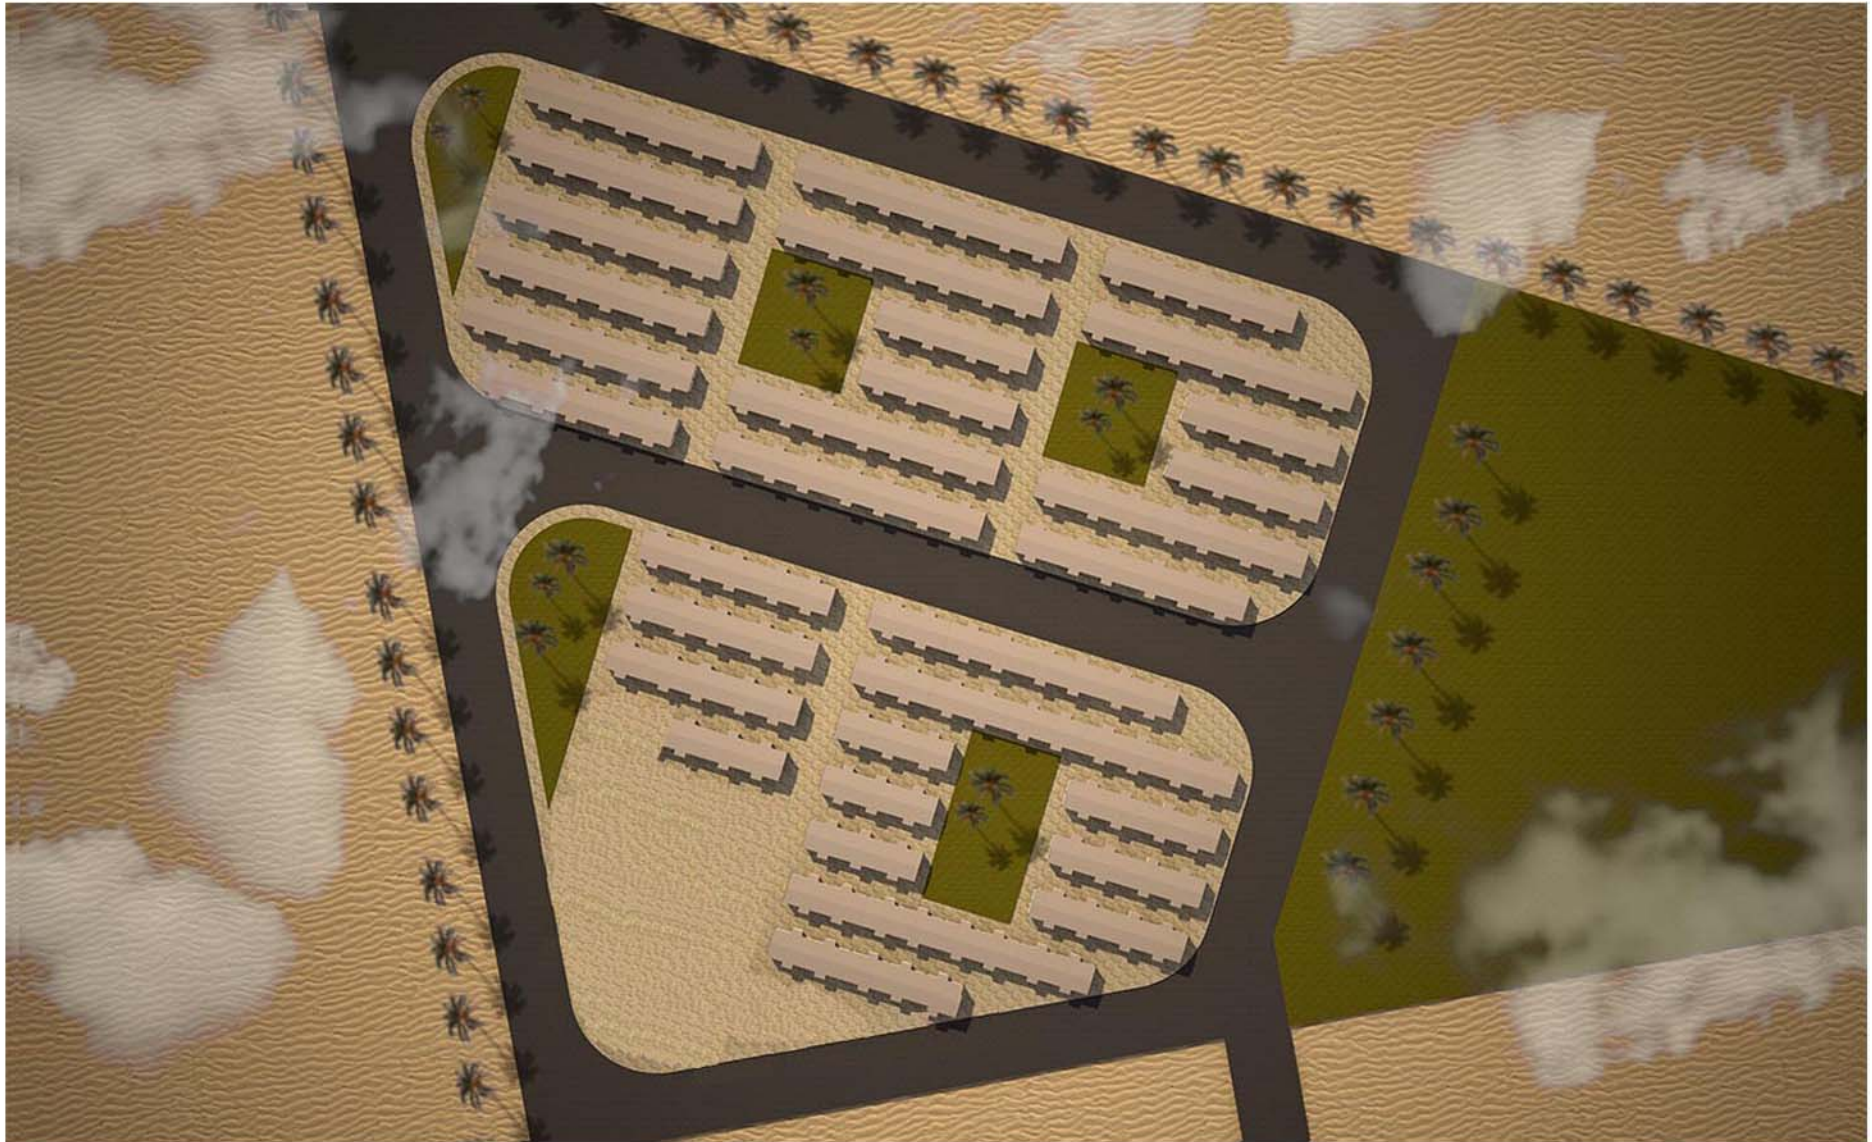

Ramadi IDP Shelter Compound
General View

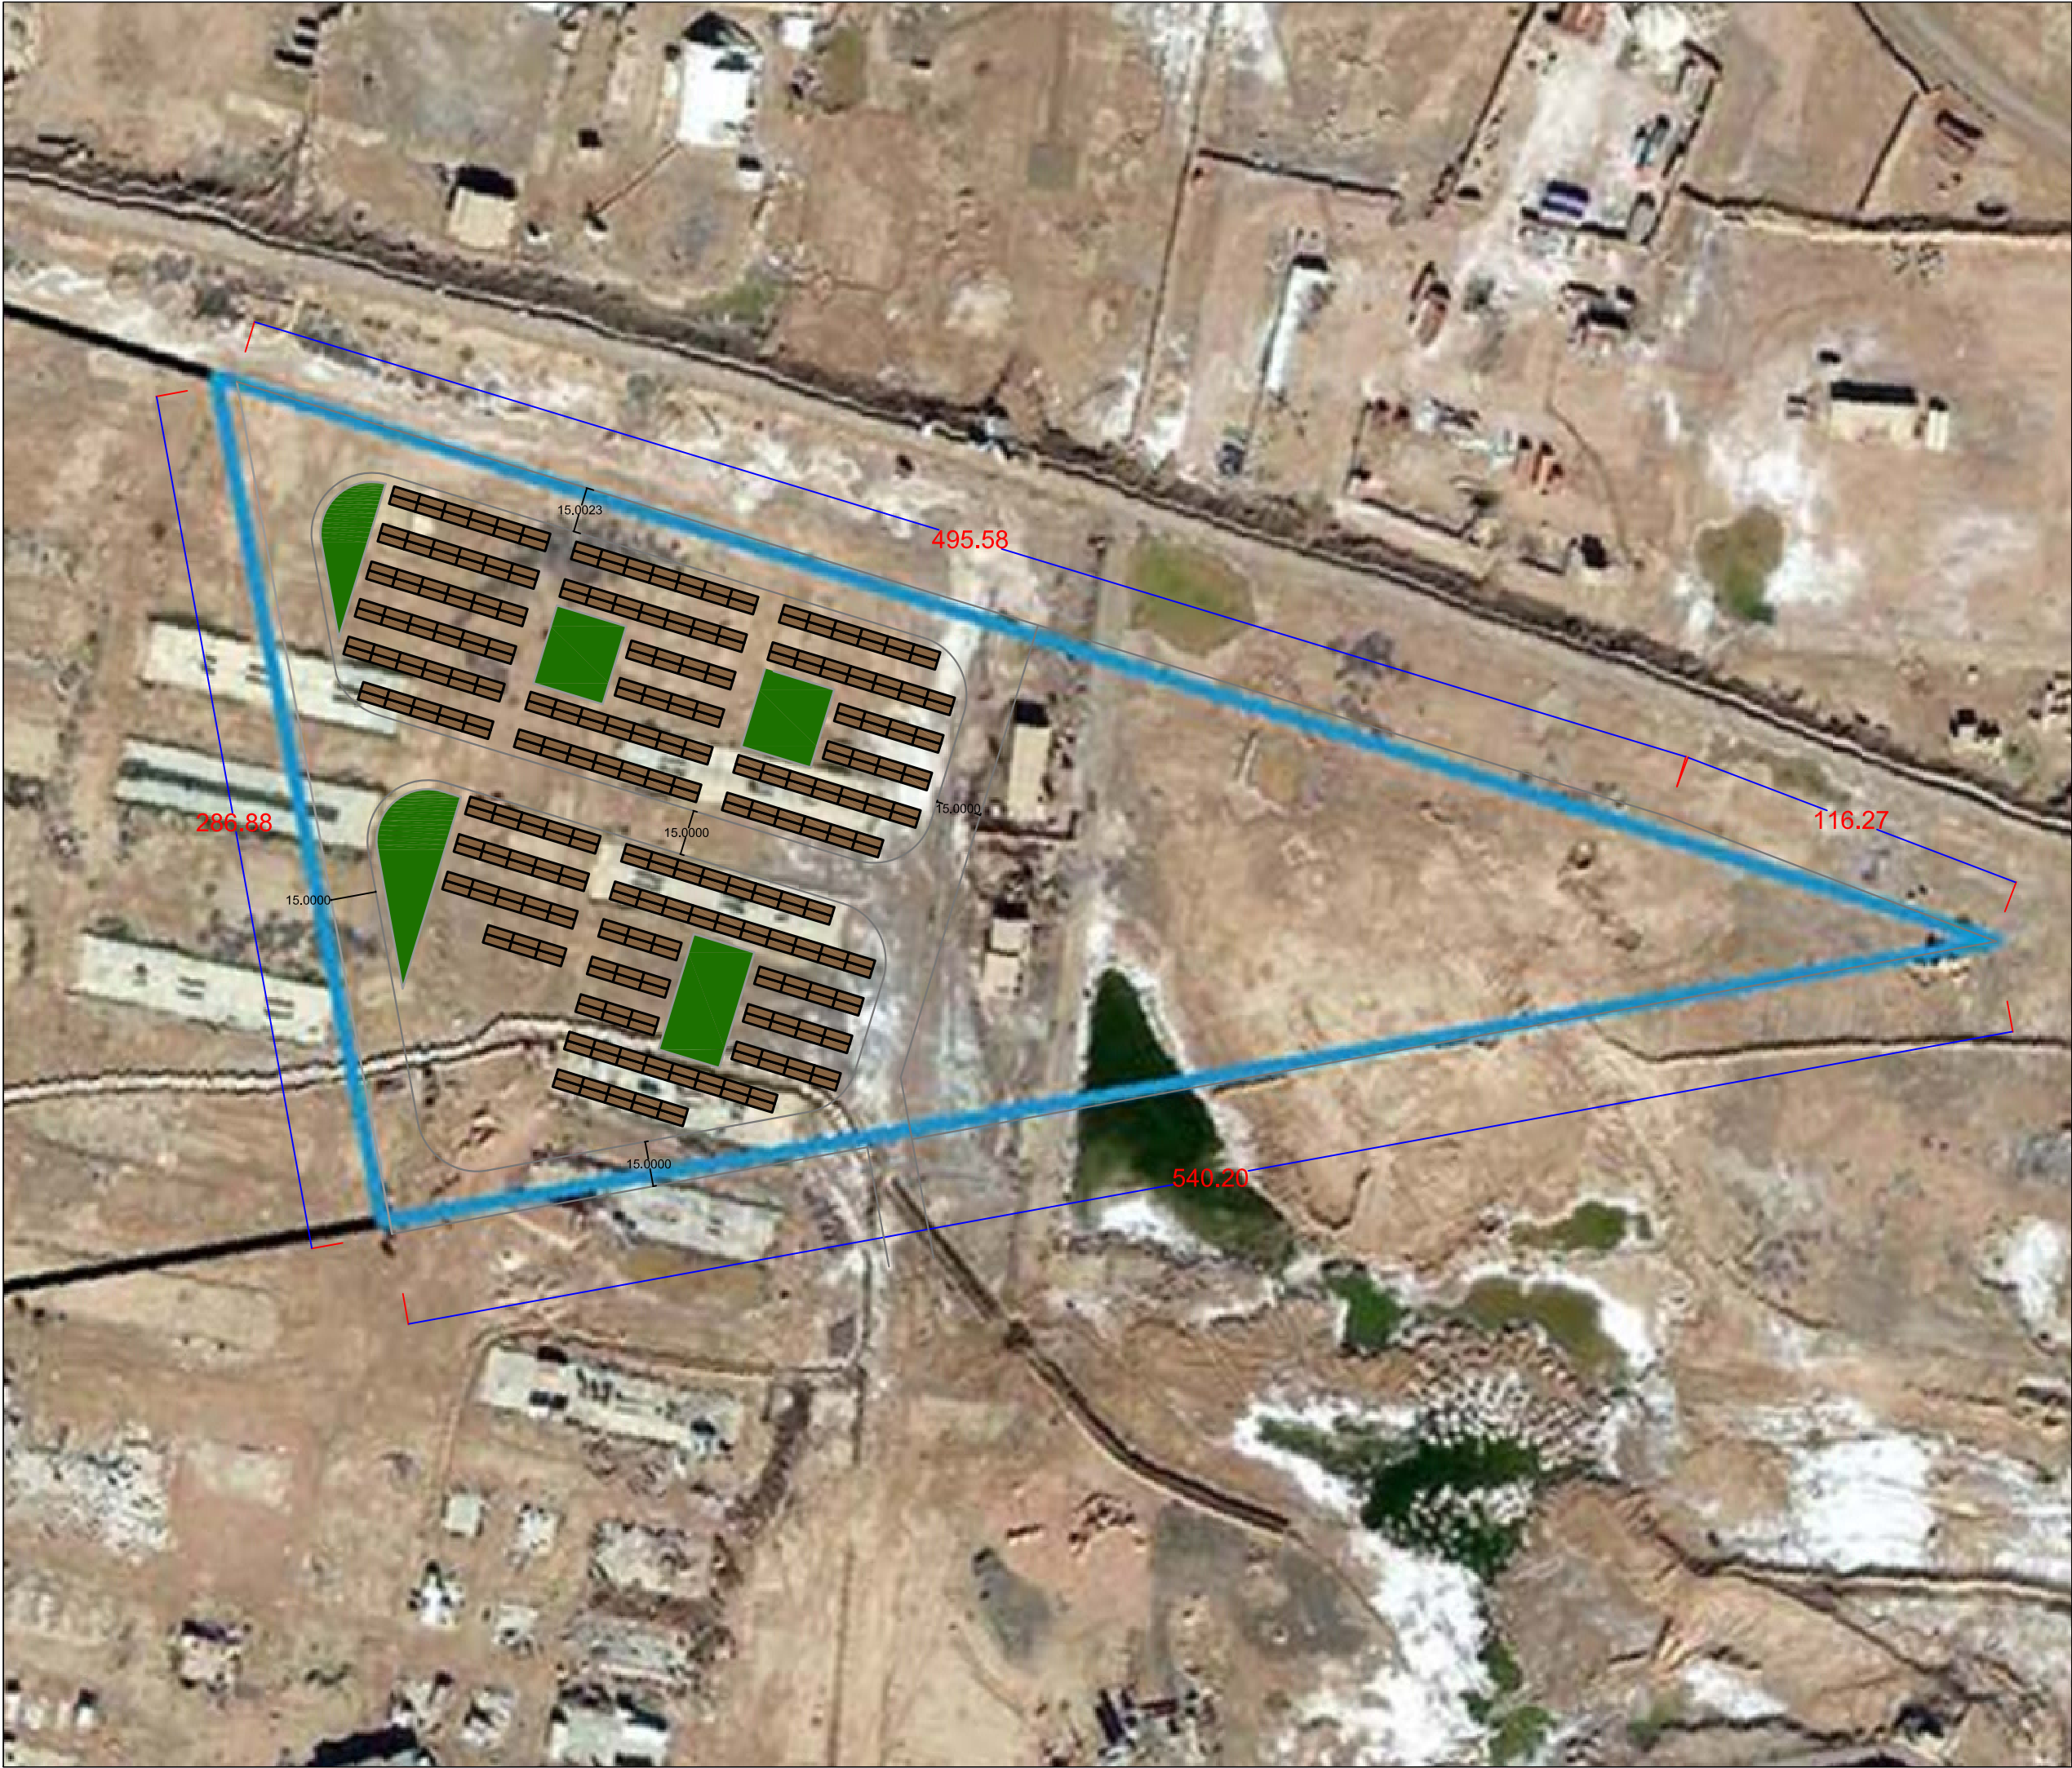


Notes:

All dimensions are in centimeters unless is noted
The copyright of this drawing remains with UN HABITAT Architects and may not be reproduced without prior written consent.
This drawing is to be read in conjunction with all other relevant drawings.

Legend:



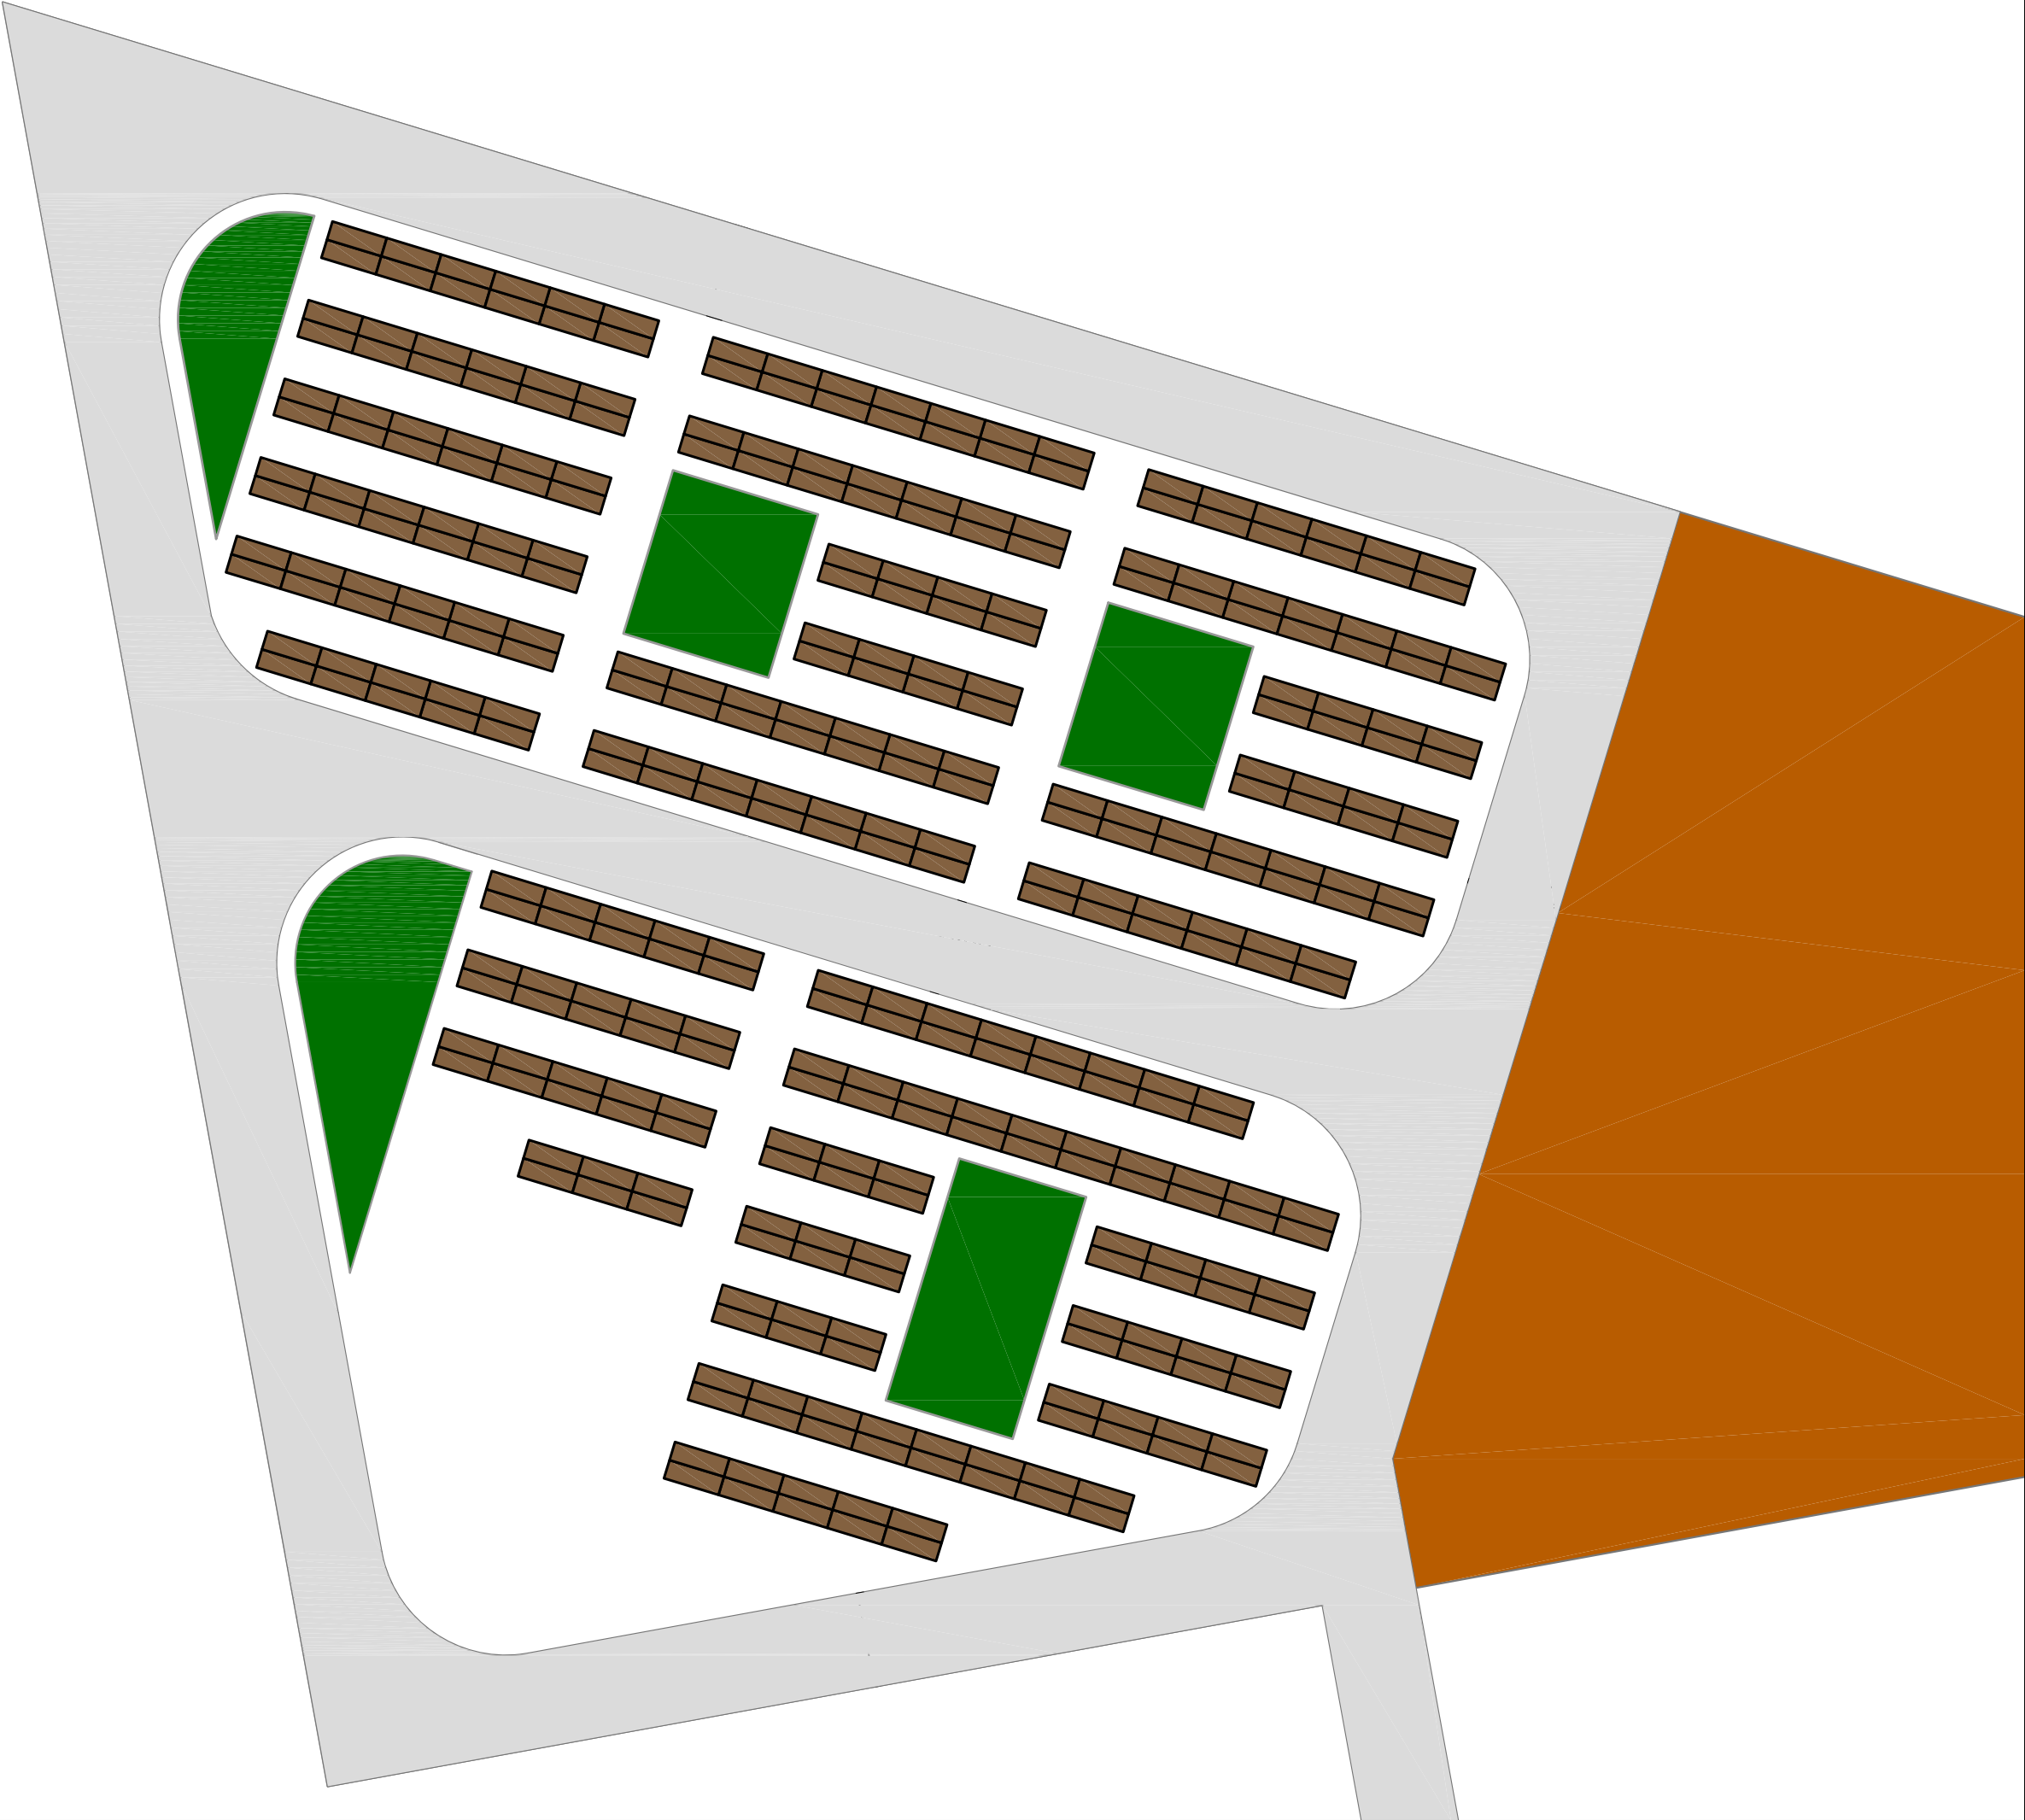


Project: Ramadi IDP shelter compound		
Drawing:Site plan		
Client: UN HABITAT		SN: AR-01
Format: A3	Scale: 1/2000	Rev: A
Drawn by:	Checked by:	Date: 02-09-2016
Approved by:	Phase: Tendering	File name:



Notes:

 All dimensions are in centimeters unless is noted
The copyright of this drawing remains with UN HABITAT Architects and may not be reproduced without prior written consent.
This drawing is to be read in conjunction with all other relevant drawings.

Legend:	
	Green area
	Road
	Future extension area



Project: Ramadi IDP shelter compound		
Drawing:Site plan		
Client: UN HABITAT		SN: AR-02
Format: A3	Scale: 1/1000	Rev: A
Drawn by:	Checked by:	Date: 02-09-2016
Approved by:	Phase: Tendering	File name:

Notes:

All dimensions are in centimeters unless is noted

The copyright of this drawing remains with UN HABITAT Architects and may not be reproduced without prior written consent.

This drawing is to be read in conjunction with all other relevant drawings.

Legend:

	Green area
	Road
	Future extension area


- Zone A 
- Zone C 
- Zone D 
- Zone E 
- Zone F 
- Zone G 
- Zone H 
- Zone I 
- Zone J 
- Zone K 
- Zone L 
- Zone M 
- Zone N 
- Zone O 




Project:
Ramadi IDP
shelter compound

Drawing:Zoning

Client: UN HABITAT		SN: AR-03
Format: A3	Scale: 1/1000	Rev: A
Drawn by:	Checked by:	Date: 02-09-2016
Approved by:	Phase: Tendering	File name:

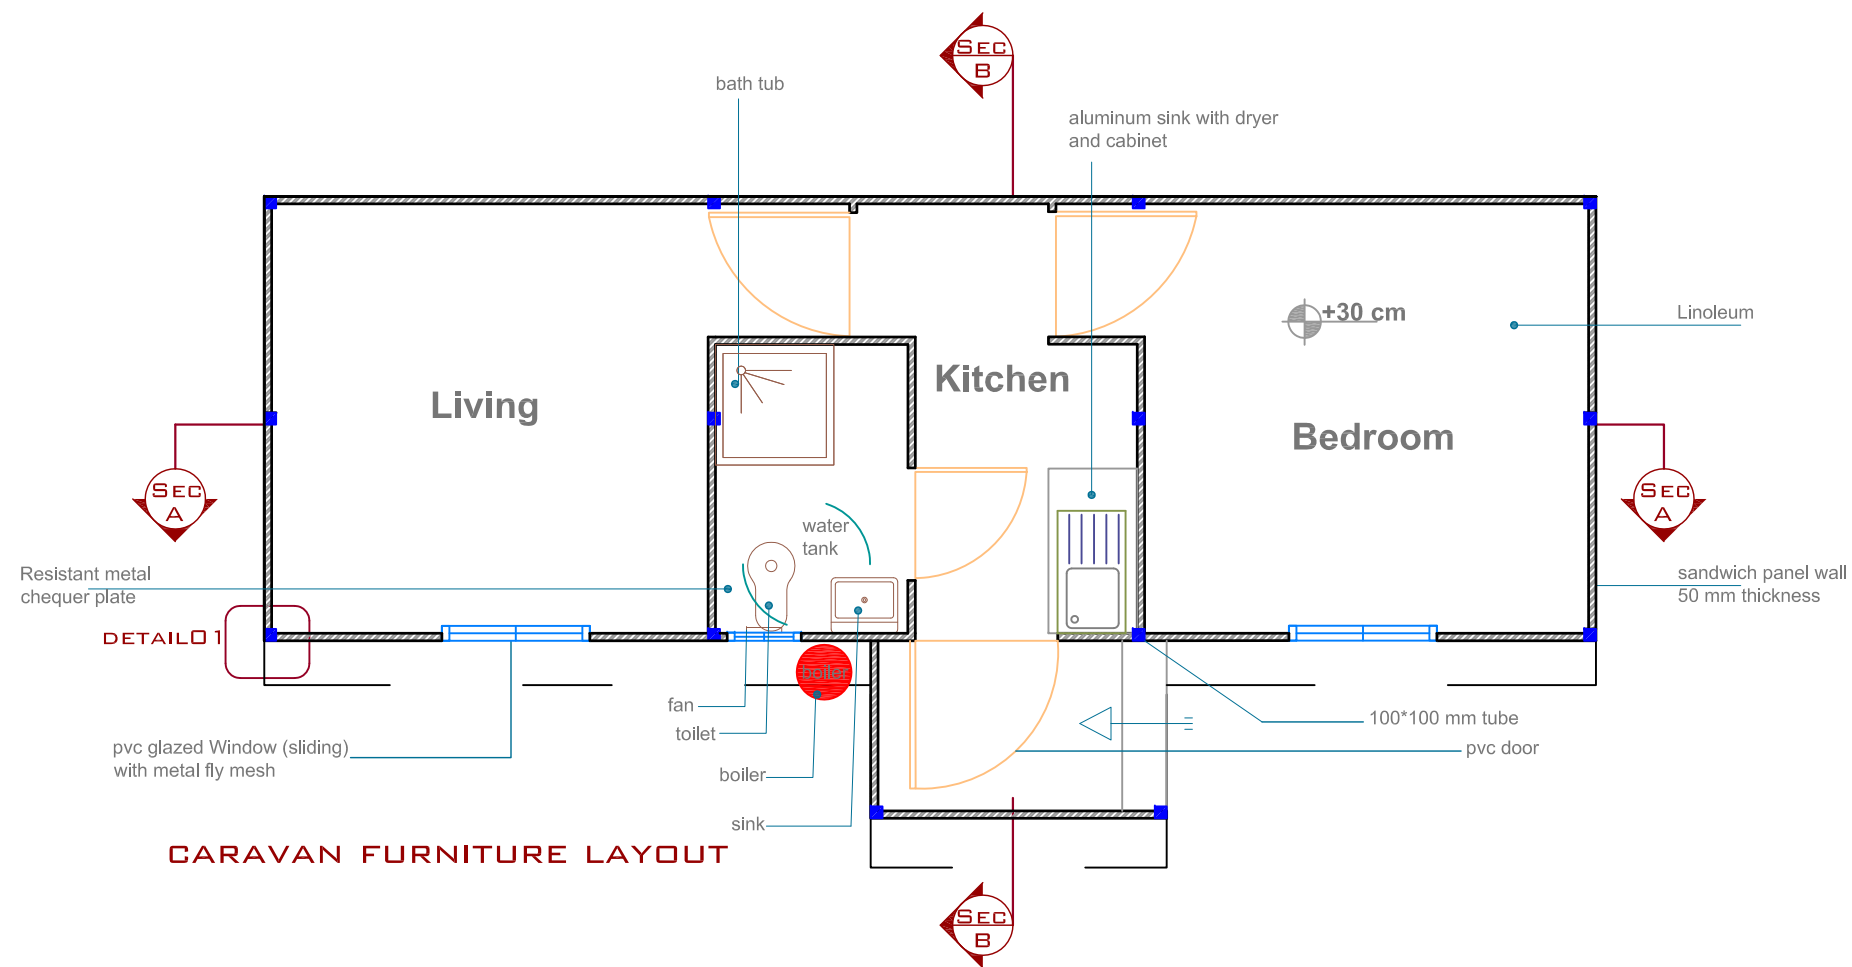

CARAVAN FURNITURE LAYOUT

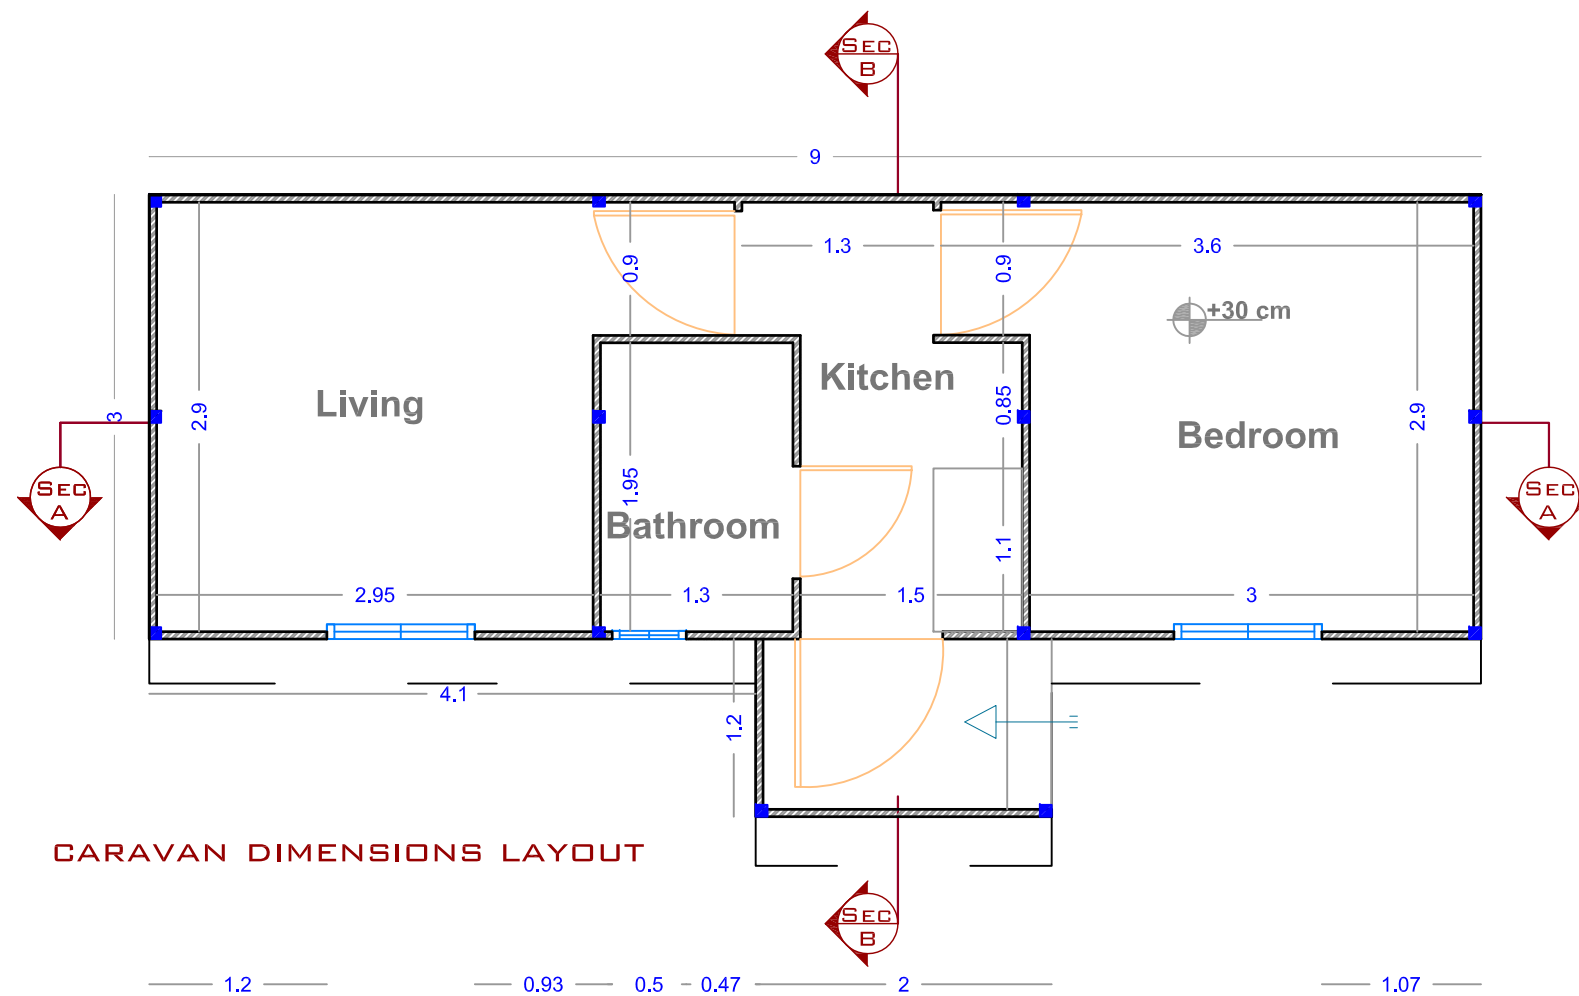

CARAVAN DIMENSIONS LAYOUT

Notes:

All dimensions are in centimeters unless is noted
The copyright of this drawing remains with **UN HABITAT** Architects and may not be reproduced without prior written consent.
This drawing is to be read in conjunction with all other relevant drawings.

Legend:




Project:
Ramadi IDP
shelter compound

Drawing: Unit plan

Client: UN HABITAT		SN: AR-03
Format: A3	Scale: 1/50	Rev: A
Drawn by:	Checked by:	Date: 07-06-2016
Approved by:	Phase: Tendering	File name:

Notes:

All dimensions are in centimeters unless is noted
The copyright of this drawing remains with
UN HABITAT Architects and may not be
reproduced without prior written consent.
This drawing is to be read in conjunction
with all other relevant drawings.

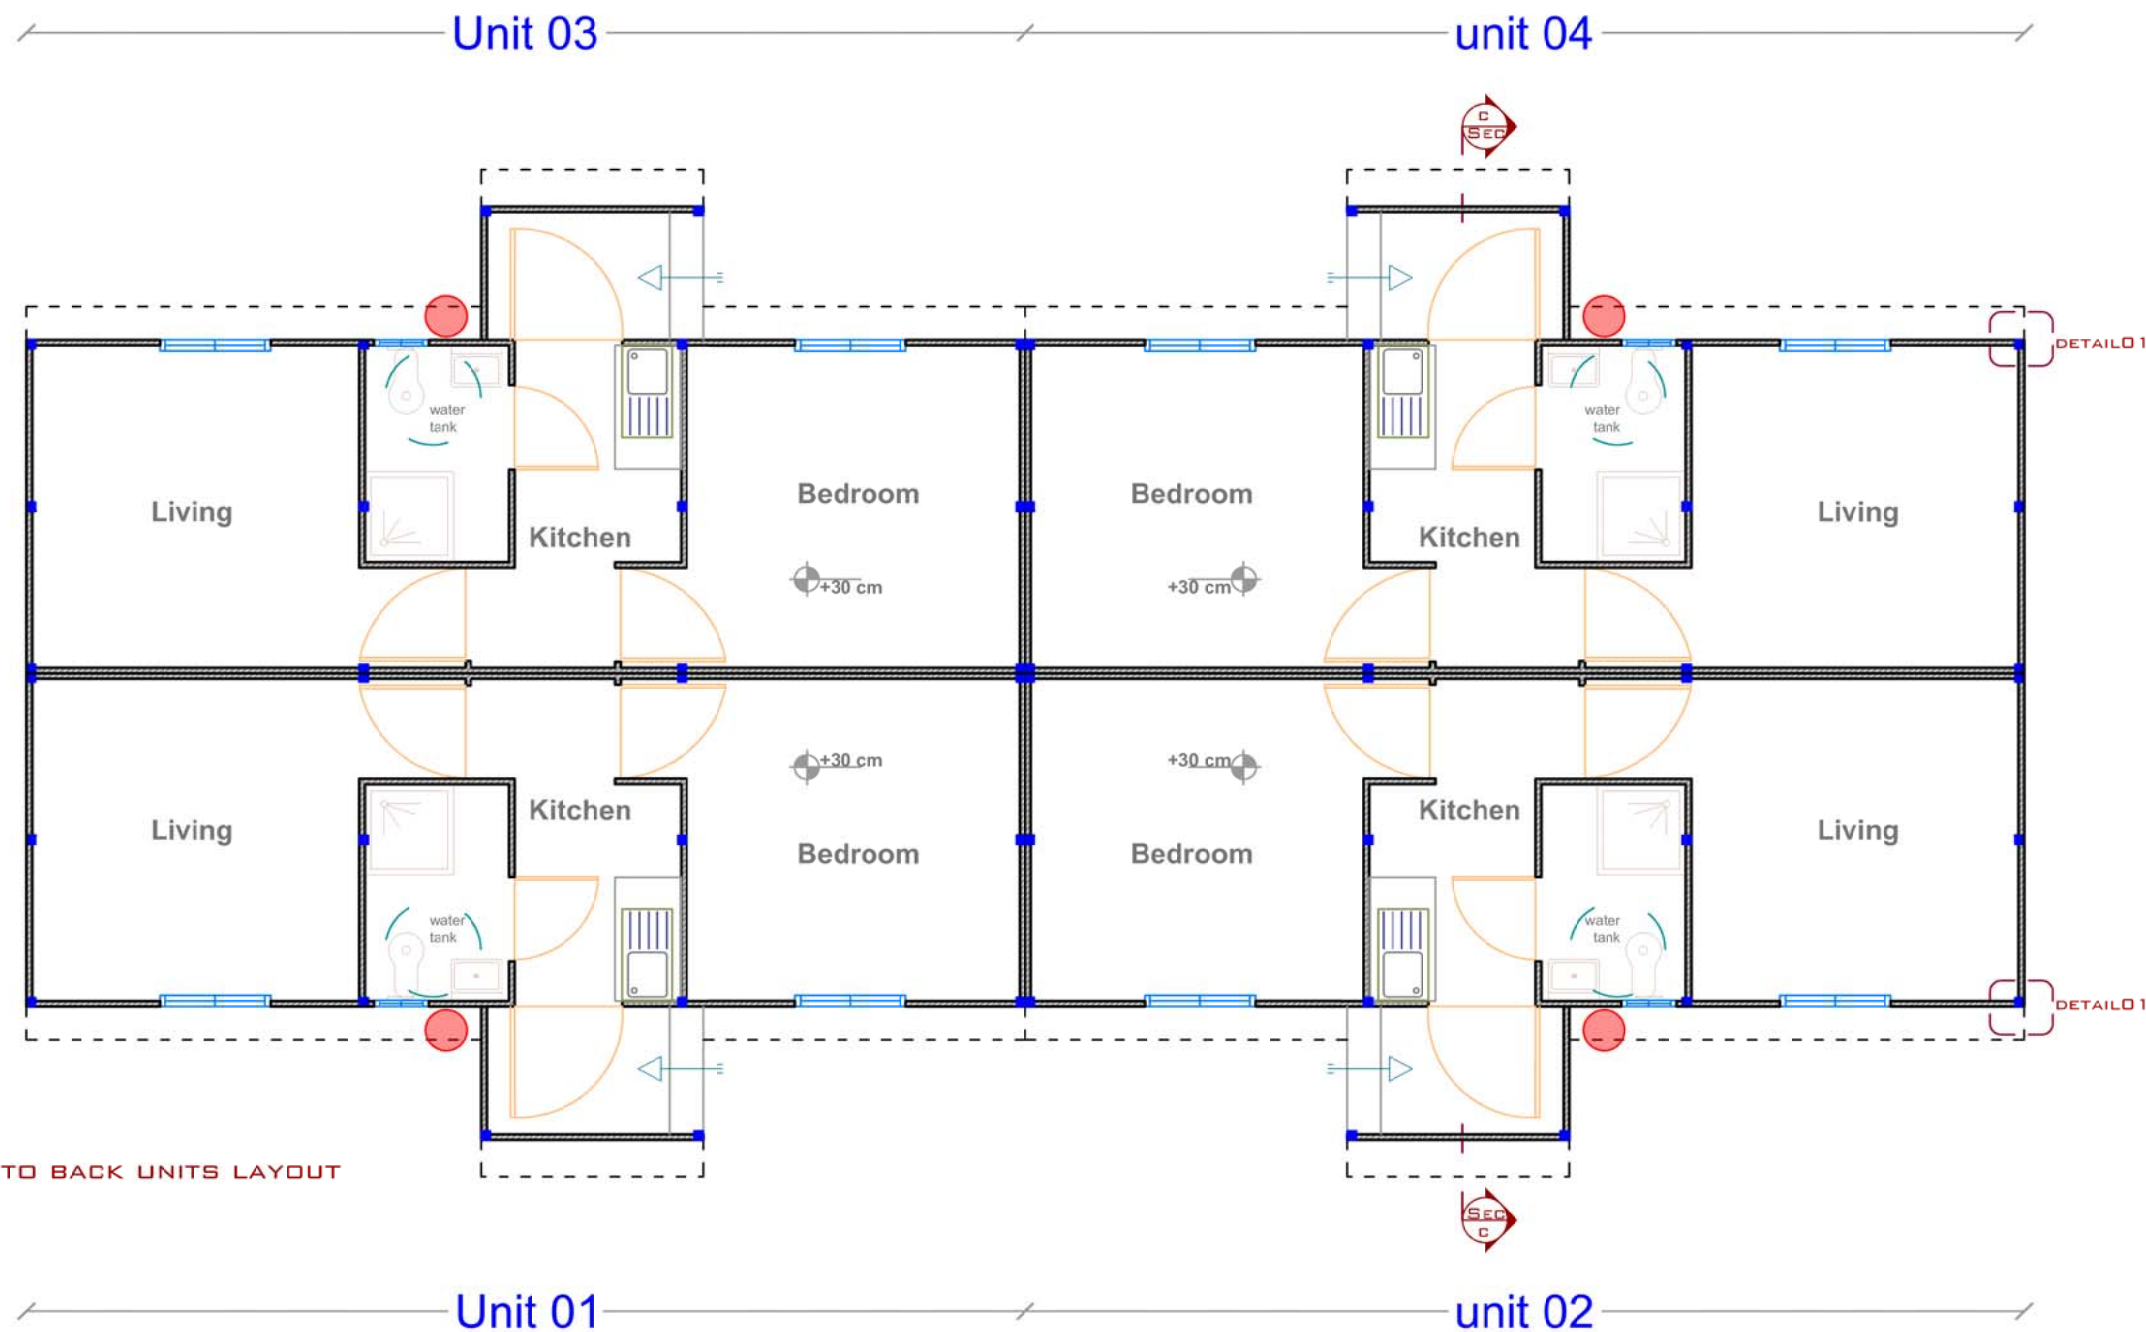Legend:

Project:
Ramadi IDP
shelter compound

Drawing: **Units back to back plans**

Client: **UN HABITAT** SN: **AR-10**

Format: **A3** Scale: **1/150** Rev: **A**

Drawn by: Checked by: Date: **07-06-2016**

Approved by: Phase: **Tendering** File name:

Sanitary Drawings



Notes:

All dimensions are in centimeters unless is noted

The copyright of this drawing remains with UN HABITAT Architects and may not be reproduced without prior written consent.

This drawing is to be read in conjunction with all other relevant drawings.

Legend:	
Symbol	Description
	2" gray pvc water sewage pipe
	4" gray pvc water sewage pipe
	6" black pvc water sewage pipe
	6" main pvc water sewage pipe
	8" main pvc water sewage pipe
	Concrete manhole 1000*1000mm
	Septis tank



Project: Ramadi IDP shelter compound		
Drawing:Site plan - Sewage network		
Client: UN HABITAT		SN: SA-01
Format: A3	Scale: None	Rev: A
Drawn by:	Checked by:	Date: 02-09-2016
Approved by:	Phase: Tendering	File name:




Notes:

All dimensions are in centimeters unless is noted


The copyright of this drawing remains with UN HABITAT Architects and may not be reproduced without prior written consent.

This drawing is to be read in conjunction with all other relevant drawings.

Legend:	
Symbol	Description
	1/2" hot water ppr pipe
	1/2" cold water ppr pipe
	3/4" clean water feed pipe
	2.5" main Polyethylene pipe
	Water tank 5000 L capacity
	Pump station
	BRC Fence

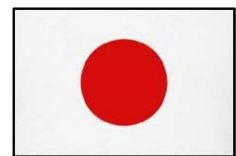

Project: Ramadi IDP shelter compound		
Drawing:Site plan - Water supply network		
Client: UN HABITAT		SN: SA-02
Format: A3	Scale: None	Rev: A
Drawn by:	Checked by:	Date: 02-09-2016
Approved by:	Phase: Tendering	File name:

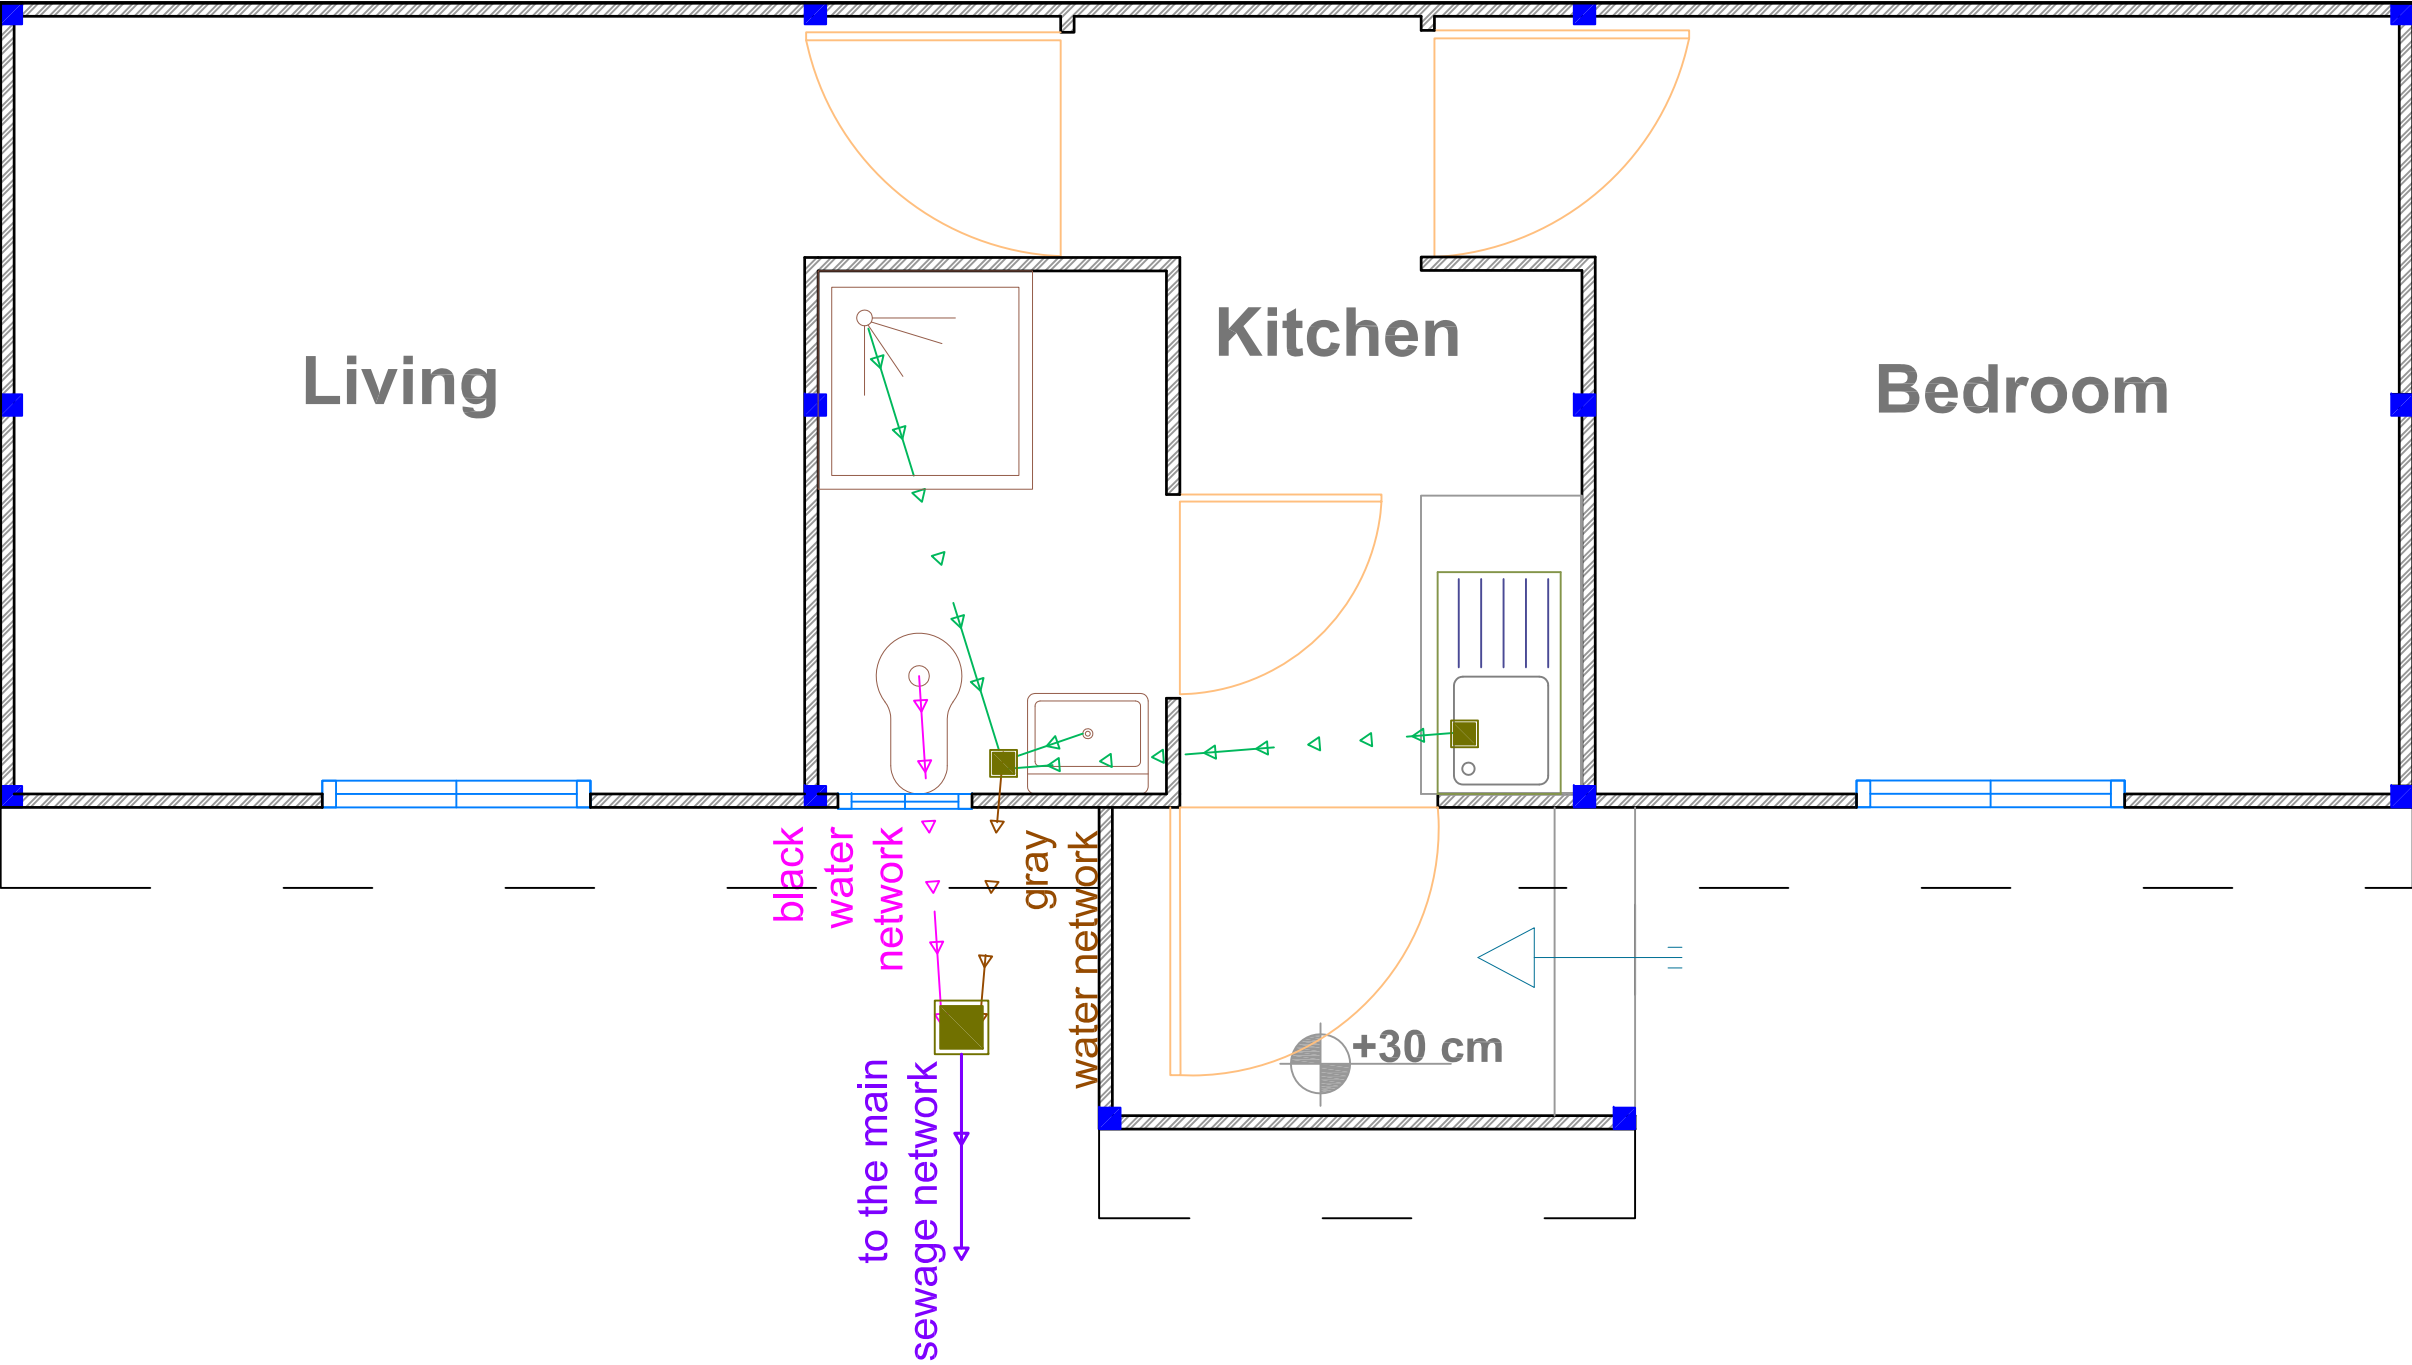

Notes:

All dimensions are in centimeters unless is noted


The copyright of this drawing remains with **UN HABITAT** Architects and may not be reproduced without prior written consent.

This drawing is to be read in conjunction with all other relevant drawings.

Legend:	
Symbol	Description
	2" gray pvc water sewage pipe
	4" gray pvc water sewage pipe
	6" black pvc water sewage pipe
	6" main pvc water sewage pipe
	8" main pvc water sewage pipe
	Concrete manhole 1000*1000mm
	Septis tank



Project: Ramadi IDP shelter compound		
Drawing:Unit Sanitary plan-sewage network		
Client: UN HABITAT		SN: SA-03
Format: A3	Scale: None	Rev: A
Drawn by:	Checked by:	Date: 07-06-2016
Approved by:	Phase: Tendering	File name:

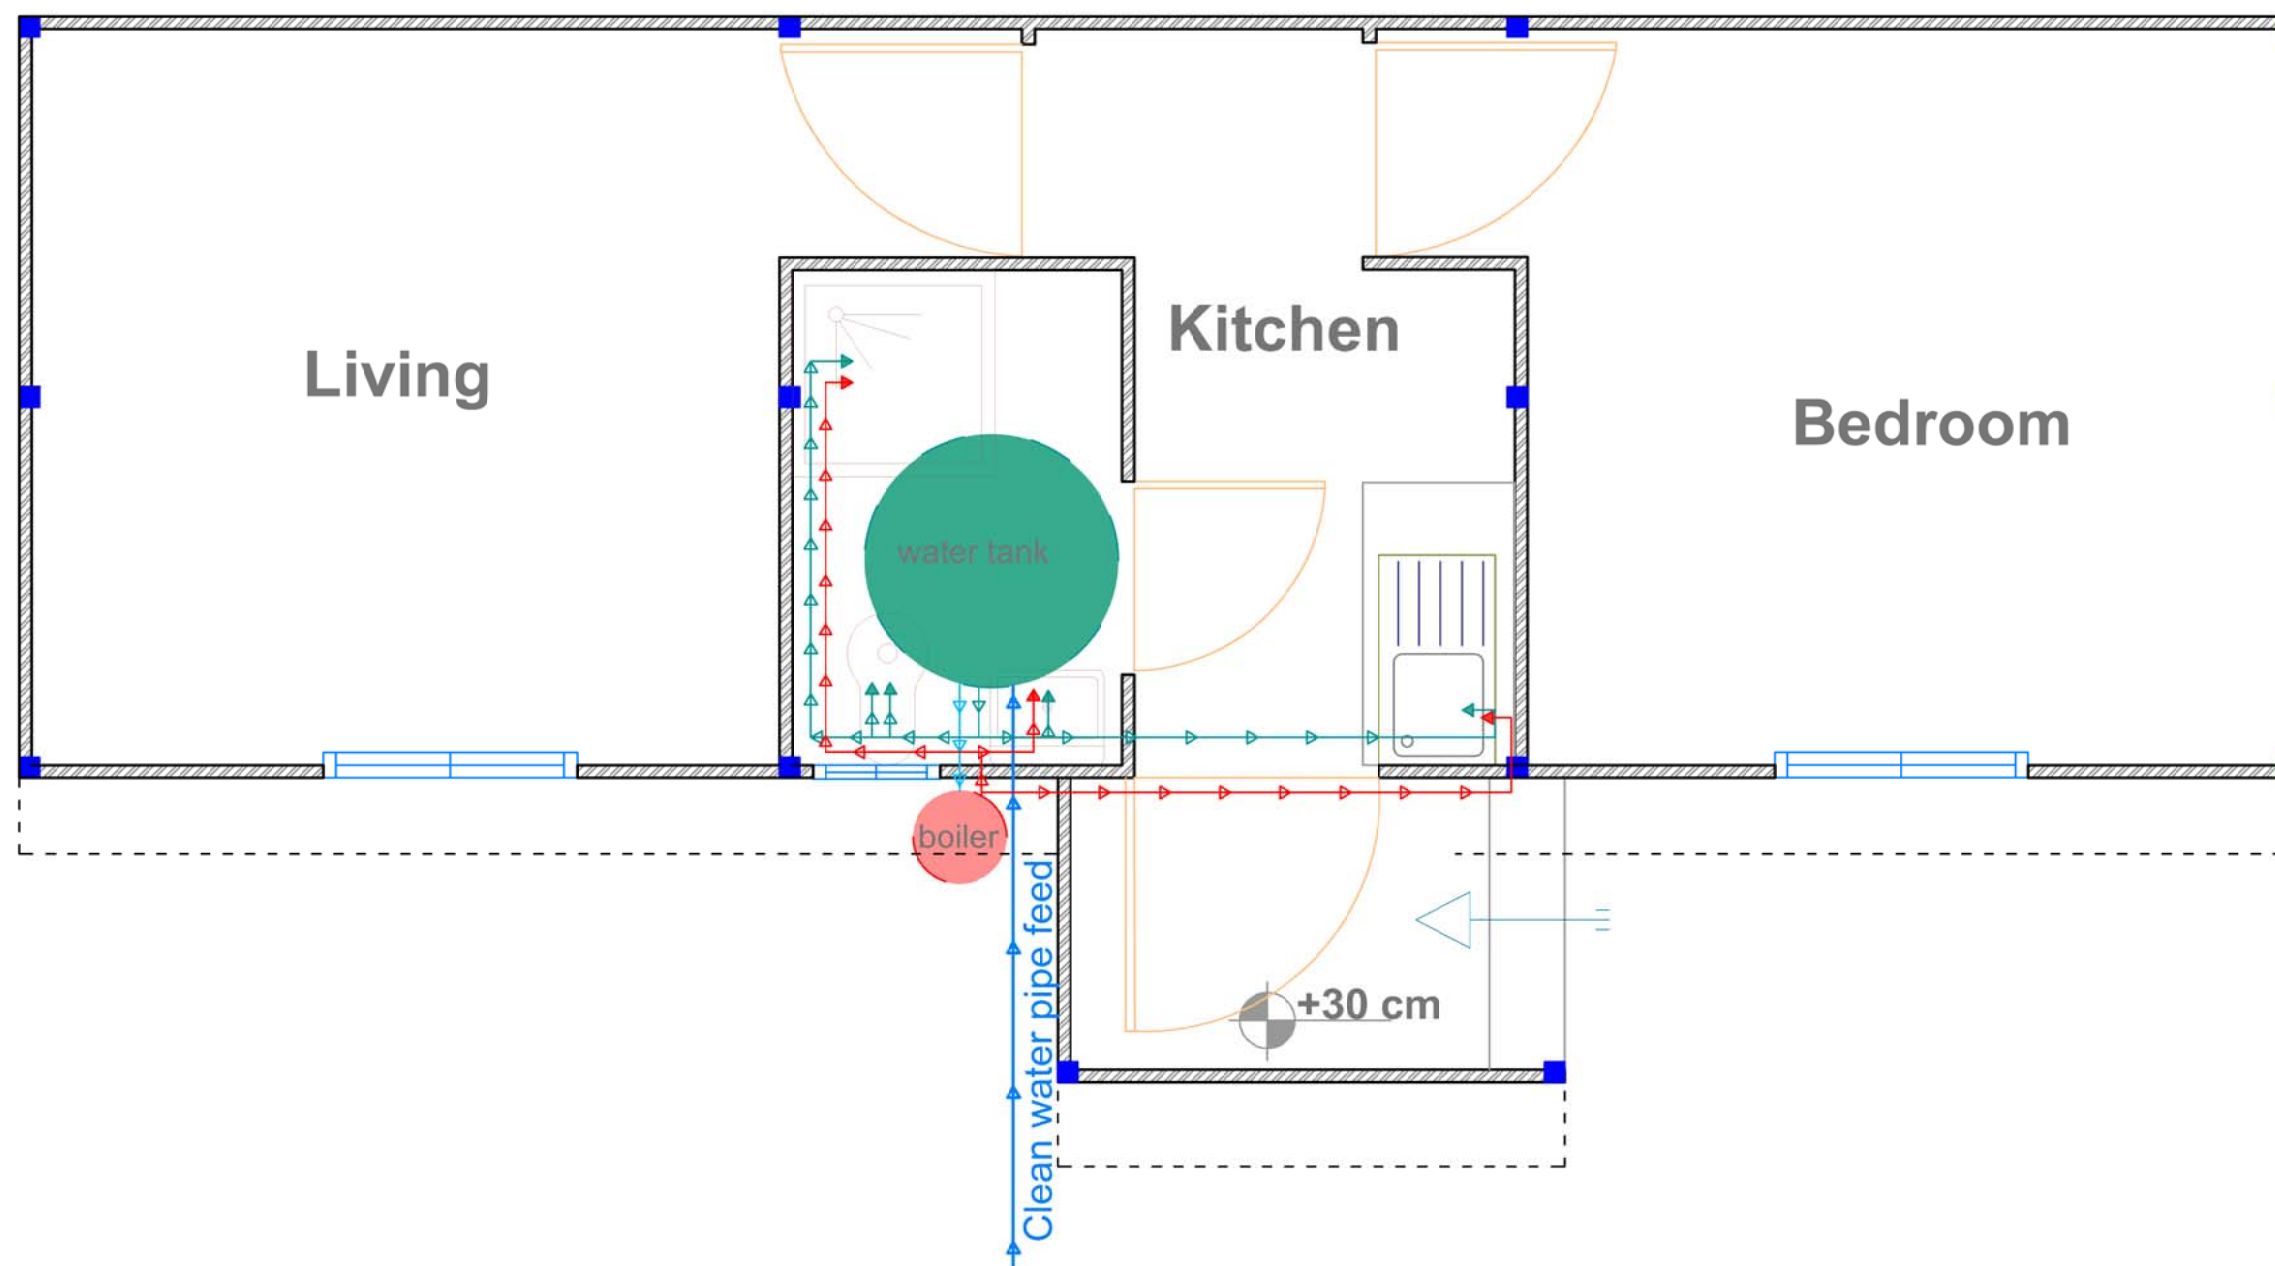

Notes:

All dimensions are in centimeters unless is noted
The copyright of this drawing remains with UN HABITAT Architects and may not be reproduced without prior written consent.
This drawing is to be read in conjunction with all other relevant drawings.

Legend:



Symbol	Description
	1/2" hot water ppr pipe
	1/2" cold water ppr pipe
	3/4" clean water feed pipe
	2.5" main Polyethylene pipe
	Unit water tank



Project:
Ramadi IDP
shelter compound

Drawing::Unit Sanitary plan-Water supply

Client: UN HABITAT		SN: SA-04
Format: A3	Scale: None	Rev: A
Drawn by:	Checked by:	Date: 07-06-2016
Approved by:	Phase: Tendering	File name:

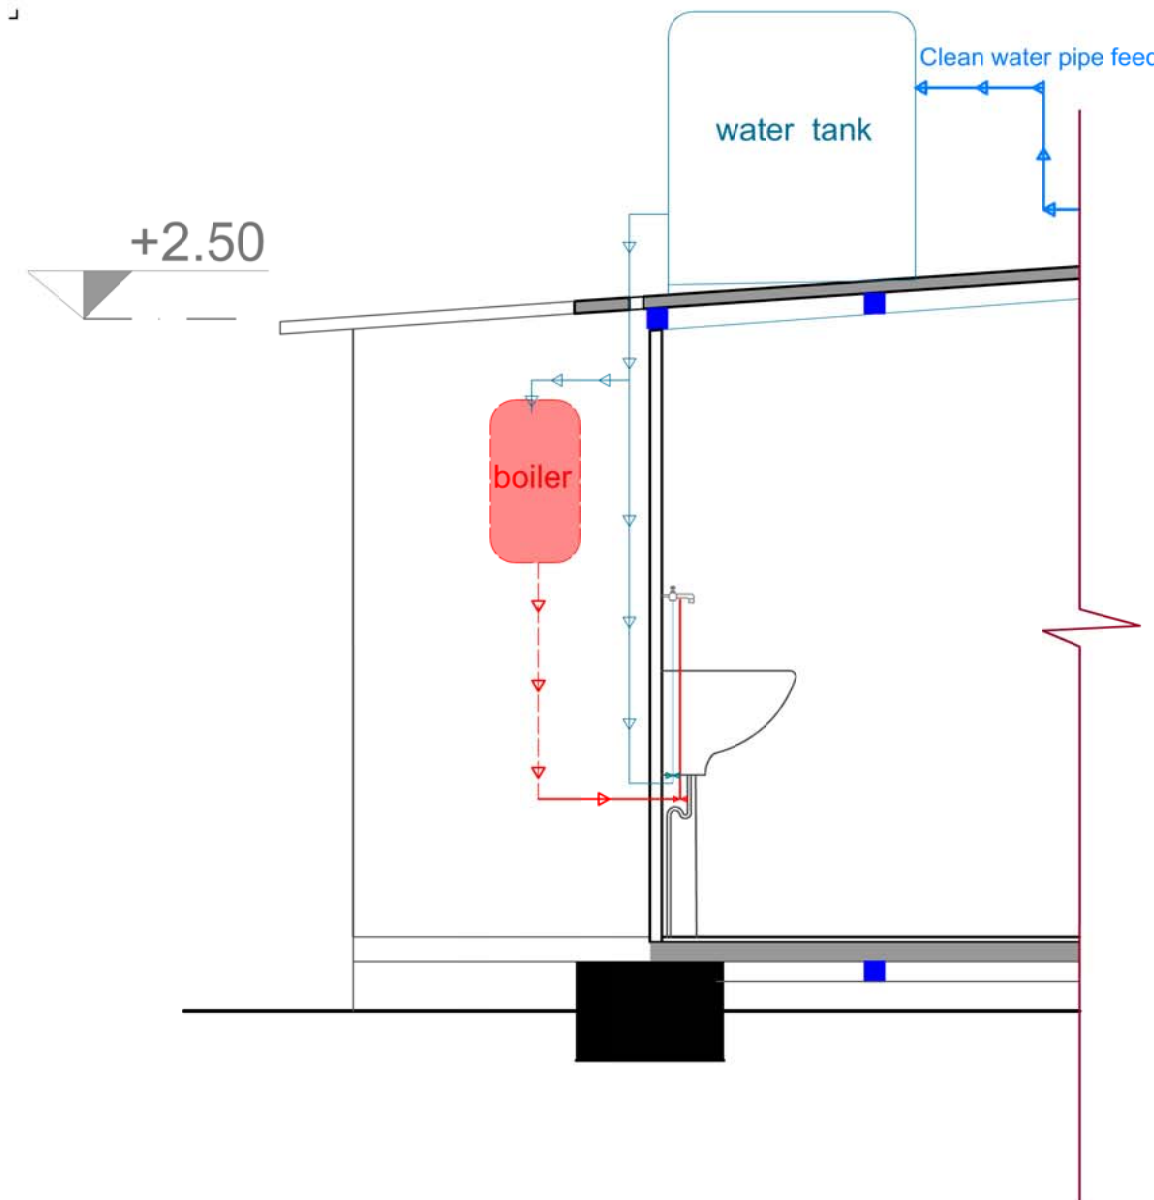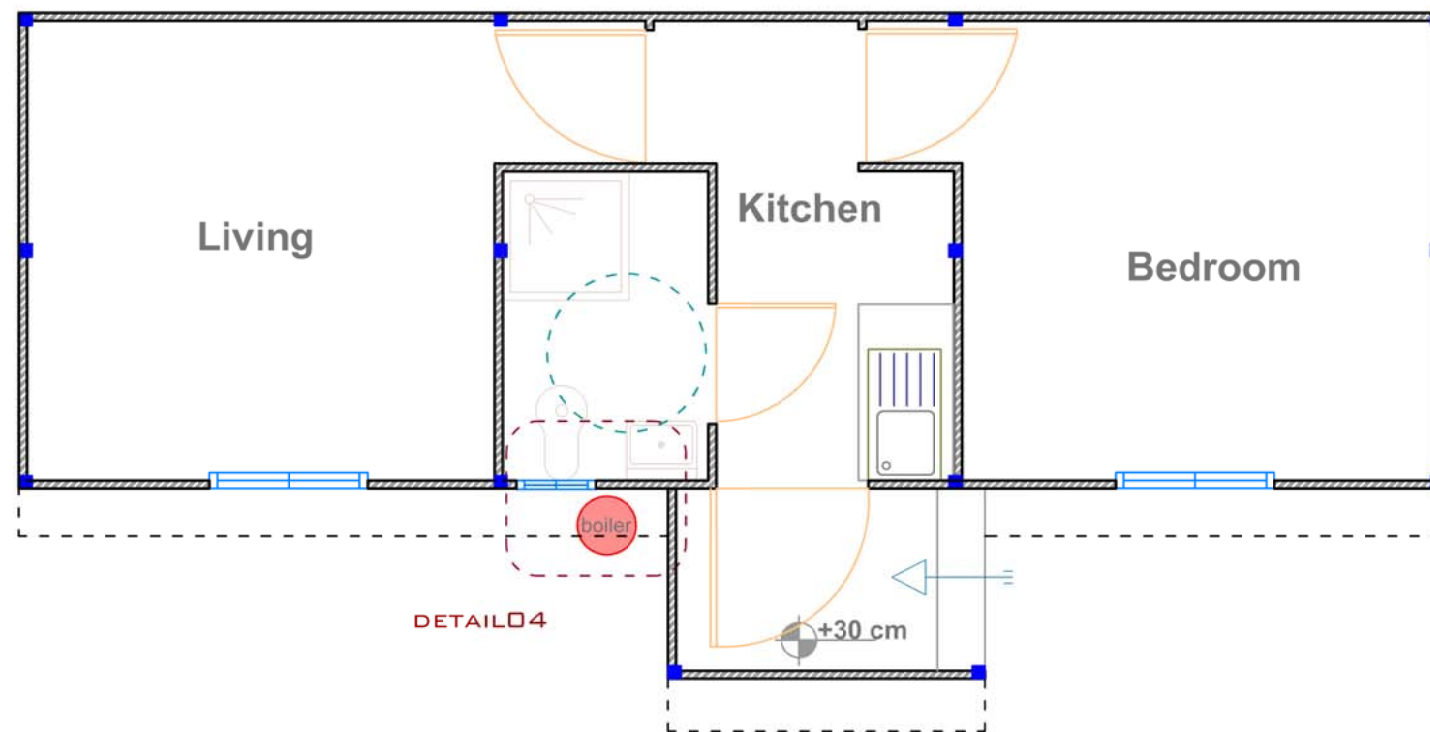

Notes:

All dimensions are in centimeters unless is noted
The copyright of this drawing remains with UN HABITAT Architects and may not be reproduced without prior written consent.
This drawing is to be read in conjunction with all other relevant drawings.

Legend:


Symbol	Description
	1/2" hot water ppr pipe
	1/2" cold water ppr pipe
	3/4" clean water feed pipe
	2.5" main Polyethylene pipe



Project:
Ramadi IDP
shelter compound

Drawing: **Unit water supply detail**


Client: UN HABITAT		SN: SA-05
Format: A3	Scale: None	Rev: A
Drawn by:	Checked by:	Date: 07-06-2016
Approved by:	Phase: Tendering	File name:

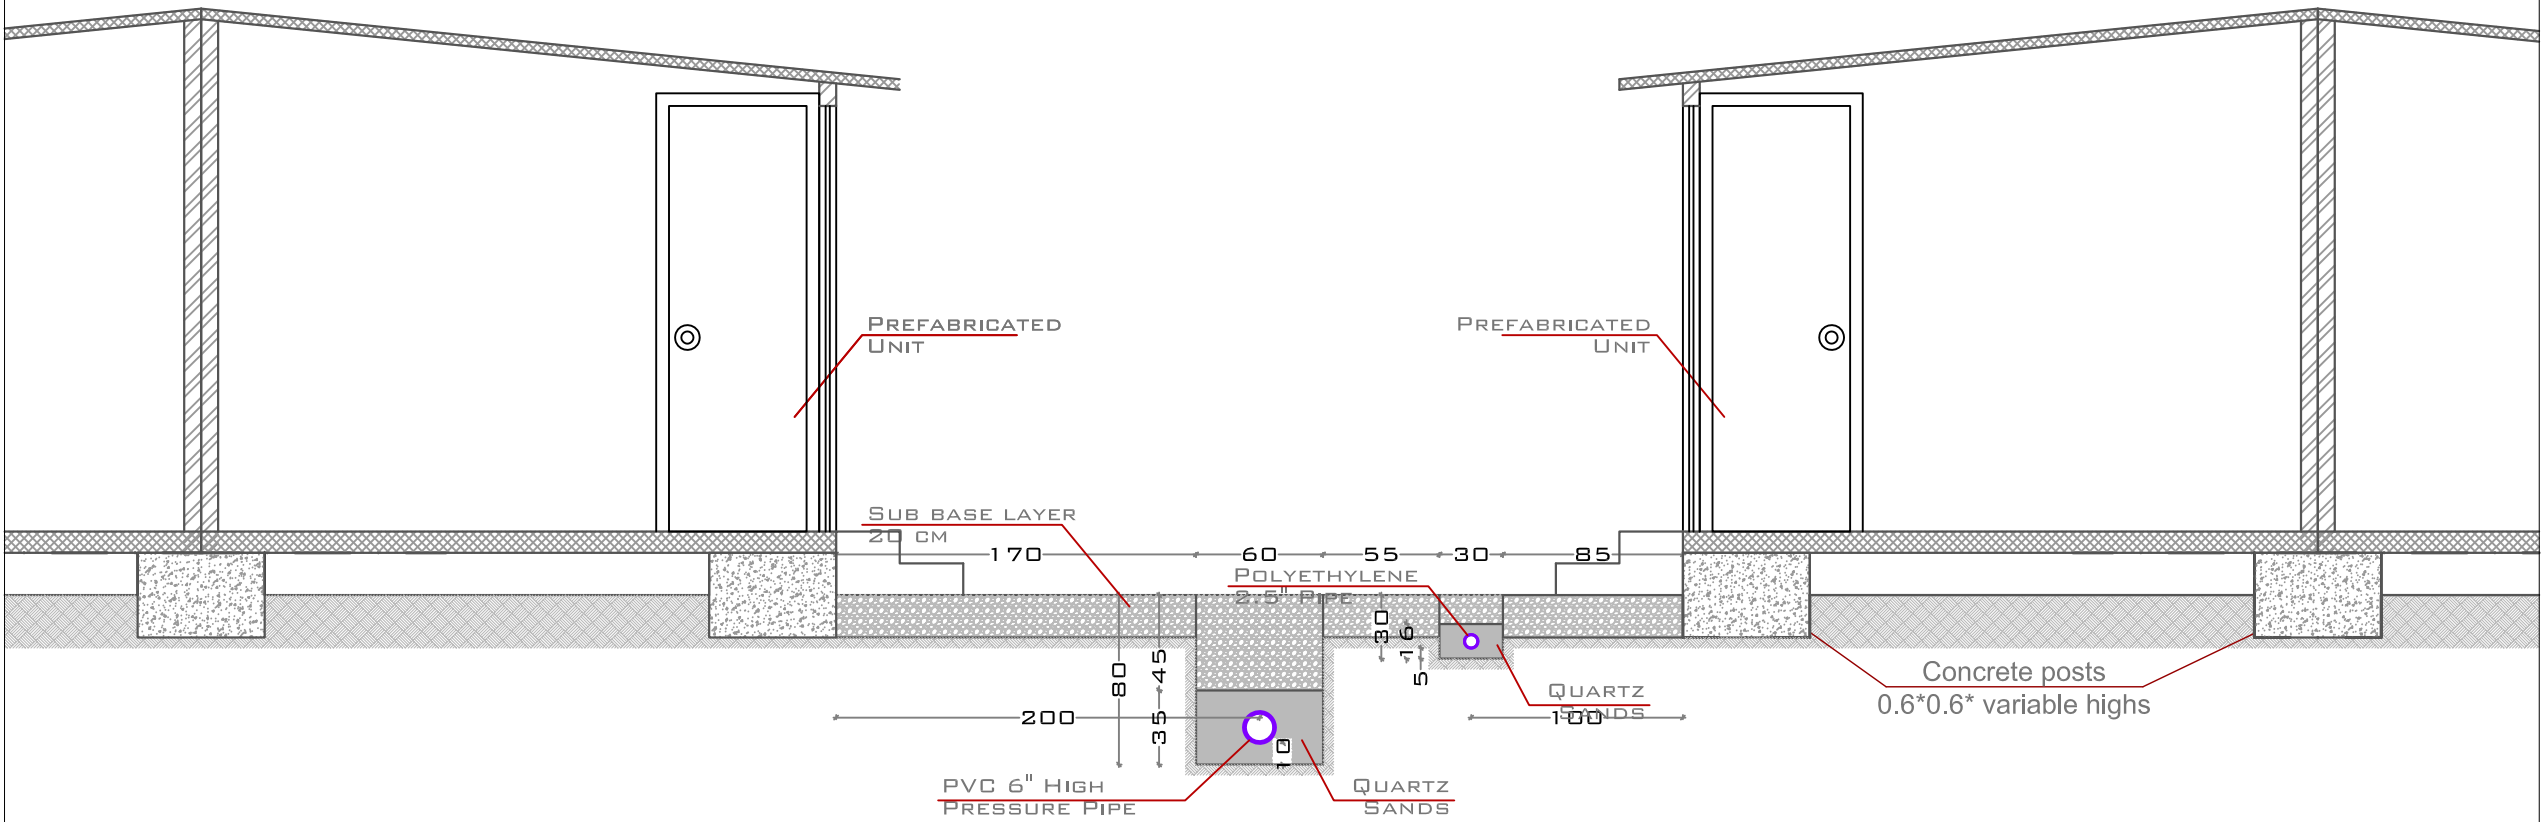

Notes:

All dimensions are in centimeters unless is noted
The copyright of this drawing remains with **UN HABITAT** Architects and may not be reproduced without prior written consent.
This drawing is to be read in conjunction with all other relevant drawings.

Legend:

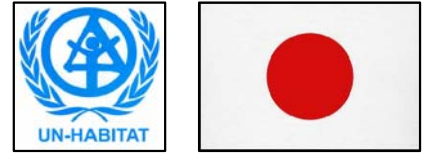

Project: Ramadi IDP shelter compound		
Drawing:Site plan - Typical section		
Client: UN HABITAT		SN: SA-06
Format: A3	Scale: None	Rev: A
Drawn by:	Checked by:	Date: 07-06-2016
Approved by:	Phase: Tendering	File name: