



THE
ROOM

DESIGN STUDIO BY MURATA

UNDP, BUILDING No 5, PHNOM PENH
ARCHITECTUREAL DETAIL DESIGN rev1 2018-04-24



PROJECT: UNDP OFFICE@PASTEUR

PHASE: DETAILED DESIGN

APRIL, 2018

DRAWING LIST

DWG N.	DRAWING NAME	SCALE	SIZE	OTHER
GENERAL				
KHATP-0221-000	MATERIAL LIST	N/A	A3	
KHATP-0221-000	SITE PICTURE	N/A	A3	
EXISTING CONDITION				
KHATP-0221-001	MASTER PLAN-EXISTING	1/100	A3	
KHATP-0221-002a	GROUND FLOOR LAYOUT-EXISTING	1/100	A3	
KHATP-0221-002b	FIRST FLOOR LAYOUT-EXISTING	1/100	A3	
KHATP-0221-002c	SECOND FLOOR LAYOUT-EXISTING	1/100	A3	
KHATP-0221-003a	EAST ELEVATION-EXISTING	1/100	A3	
KHATP-0221-003b	SOUTH ELEVATION-EXISTING	1/100	A3	
KHATP-0221-003c	WEST ELEVATION-EXISTING	1/100	A3	
KHATP-0221-003d	NORTH ELEVATION-EXISTING	1/100	A3	
KHATP-0221-004a	MASTER & GROUND LAYOUT - DEMOLITION	1/100	A3	
KHATP-0221-004b	FIRST FLOOR LAYOUT-DEMOLITION	1/100	A3	
KHATP-0221-004c	SECOND FLOOR LAYOUT-EXISTING	1/100	A3	
KHATP-0221-005a	EAST ELEVATION-DEMOLITION	1/100	A3	
KHATP-0221-005b	SOUTH ELEVATION-DEMOLITION	1/100	A3	
KHATP-0221-005c	WEST ELEVATION-DEMOLITION	1/100	A3	
KHATP-0221-005D	NORTH ELEVATION-DEMOLITION	1/100	A3	
KHATP-0221-006a	GROUND FLOOR-WINDOW DEMOLITION	1/100	A3	
KHATP-0221-006b	FIRST FLOOR-WINDOW DEMOLITION	1/100	A3	
KHATP-0221-006c	SECOND FLOOR-WINDOW DEMOLITION	1/100	A3	
PRELIMINARY DESIGN				
KHATP-0221-100	MASTER PLAN	1/100	A3	
KHATP-0221-101a	GROUND FLOOR LAYOUT	1/100	A3	
KHATP-0221101b	FIRST FLOOR LAYOUT	1/100	A3	
KHATP-0221-101c	SECOND FLOOR LAYOUT	1/100	A3	
KHATP-0221-102a	FURNITURE FIGURE POINT-GROUND FLOOR	1/100	A3	
KHATP-0221-102b	FURNITURE FIGURE POINT-SECOND FLOOR	1/100	A3	
KHATP-0221-102c	FURNITURE FIGURE POINT-THIRD FLOOR	1/100	A3	
KHATP-0221-103a	ELECTRICAL LAYOUT-GROUND FLOOR	1/100	A3	
KHATP-0221-103b	ELECTRICAL LAYOUT-FIRST FLOOR	1/100	A3	
KHATP-0221-103c	ELECTRICAL LAYOUT-SECOND FLOOR	1/100	A3	

DWG N.	DRAWING NAME	SCALE	SIZE	OTHER
KHATP-0221-104a	CEILING&LIGTHING LAYOUT-GROUND FLOOR	1/100	A3	
KHATP-0221-104b	CEILING&LIGTHING LAYOUT-FIRST FLOOR	1/100	A3	
KHATP-0221-104c	CEILING&LIGTHING LAYOUT-SECOND FLOOR	1/100	A3	
KHATP-0221-105a	FLOOR FINISHING LAYOUT-GROUND FLOOR	1/100	A3	
KHATP-0221-105b	FLOOR FINISHING LAYOUT-FIRST FLOOR	1/100	A3	
KHATP-0221-105c	FLOOR FINISHING LAYOUT-SECOND FLOOR	1/100	A3	
KHATP-0221-201	EAST ELEVATION-REFURB	1/100	A3	
KHATP-0221-202	SOUTH ELEVATION-REFURB	1/100	A3	
KHATP-0221-203	WEST ELEVATION-REFURB	1/100	A3	
KHATP-0221-204	NORTH ELEVATION-REFURB	1/100	A3	
KHATP-0221-301	INTERNAL ELEVATION-COURTYARD AA	1/100	A3	
DOOR AND GLASS PARTITION SCHEDULES				
KHATP-0221-DS-01	DOOR SCHEDULE	1/50	A3	
KHATP-0221-DS-02	DOOR SCHEDULE	1/50	A3	
KHATP-0221-DS-03	DOOR SCHEDULE	1/50	A3	
KHATP-0221-DS-04	DOOR SCHEDULE	1/50	A3	
KHATP-0221-GS-01	GLASS PARTITION SCHEDULES	1/50	A3	
KHATP-0221-GS-02	GLASS PARTITION SCHEDULES	1/50	A3	
KHATP-0221-GS-03	GLASS PARTITION SCHEDULES	1/50	A3	
KHATP-0221-GS-04	GLASS PARTITION SCHEDULES	1/50	A3	
KHATP-0221-GS-05	GLASS PARTITION SCHEDULES	1/50	A3	
KHATP-0221-GS-06	GLASS PARTITION SCHEDULES	1/50	A3	
KHATP-0221-GS-07	GLASS PARTITION SCHEDULES	1/50	A3	
KHATP-0221-GS-08	GLASS PARTITION SCHEDULES	1/50	A3	
KHATP-0221-GD-09	GLASS PARTITION&DOOR TYPICAL DETAIL	A.S	A3	
WINDOW SHCHEDULE				
KHATP-0221-WS-01	WINDOW SCHEDULE	1/50	A3	
KHATP-0221-WS-02	WINDOW SCHEDULE	1/50	A3	

DWG N.	DRAWING NAME	SCALE	SIZE	OTHER
GENERAL DETAILS				
KHATP-0221-ID-01a	FL.0.14:DISABLE& FL.0.15:MALE TOILET(GF)-LAYOUT	1/25	A3	
KHATP-0221-ID-01b	FL.0.14:DISABLE&FL.0.15:MALE TOILET(GF)-LAYOUT	1/25	A3	
KHATP-0221-ID-01C	FL.0.14:DISABLE&FL.0.15:MALE TOILET(GF)-ELEVATION	1/25	A3	
KHATP-0221-ID-01D	FL.0.14:DISABLE& FL.0.15:MALE TOILET(GF)-ELEVATION	1/25	A3	
KHATP-0221-ID-02a	FL.0.13:STAFF TOILET(GF)-LAYOUT	1/25	A3	
KHATP-0221-ID-02b	FL.0.13:STAFF TOILET(GF)-ELEVATION	1/25	A3	
KHATP-0221-ID-03a	FL.0.20:SECURITY GUARD TOILET(GF)-LAYOUT	1/25	A3	
KHATP-0221-ID-04a	FL.1.13: FEMALE TOILET(1F)-LAYOUT	1/25	A3	
KHATP-0221-ID-04b	FL.1.13: FEMALE TOILET(1F)-ELEVATION	1/25	A3	
KHATP-0221-ID-05a	FL.2.04: FEMALE&FL.2.05:MALE TOILET(2F)-LAYOUT	1/25	A3	
KHATP-0221-ID-05b	FL.2.04: FEMALE&FL.2.05:MALE TOILET(2F)-LAYOUT	1/25	A3	
KHATP-0221-ID-05c	FL.2.04: FEMALE& FL.2.05:MALE TOILET)-LELEVATION	1/25	A3	
KHATP-0221-ID-05d	FL.2.04: FEMALE& FL.2.05:MALE TOILET)-LELEVATION	1/25	A3	
KHATP-0221-ID-06	WINDOW ROOF DETAIL	A.S	A3	
KHATP-0221-ID-07	EMERGENCY STAIRCASE	1/25	A3	
KHATP-0221-ID-08	FENCH REFURB	1/75	A3	
KHATP-0221-ID-09	PARKING LOT	1/50	A3	
KHATP-0221-ID-10	EXTENSION BUILDING DETAIL	A.S	A3	
MISCELLANEOUS DETAILS				
KHATP-0221-MD-01	RECEPTION COUNTER DETAIL	A.S	A3	
KHATP-0221-MD-02	PANTRY COUNTER DETAIL	A.S	A3	
KHATP-0221-MD-03	WINDDOW STEEL BAR DETAIL	1/50	A3	
KHATP-0221-MD-04	UNDP ARTWORK AND STEEL MESH DETAIL	1/75	A3	
KHATP-0221-MD-05a	CABINET DETAIL-N.FE.10a	1/10	A3	
KHATP-0221-MD-05b	CABINET DETAIL-N.FE.10b	A.S	A3	
KHATP-0221-MD-05c	CABINET DETAIL-N.FE.10c	A.S	A3	
KHATP-0221-MD-05d	CABINET DETAIL-N.FE.10d	A.S	A3	
KHATP-0221-MD-05d	CABINET DETAIL-N.FE.10d	A.S	A3	
KHATP-0221-MD-05e	CABINET DETAIL-N.FE.10e	A.S	A3	
KHATP-0221-MD-05f	CABINET DETAIL-N.FE.10f	A.S	A3	
KHATP-0221-MD-05g	CABINET DETAIL-N.FE.10g	A.S	A3	
KHATP-0221-MD-05h	CABINET DETAIL-N.FE.10h	A.S	A3	
KHATP-0221-MD-05i	CABINET DETAIL-N.FE.10i	1/10	A3	
KHATP-0221-MD-05j	CABINET DETAIL-N.FE.10j	A.S	A3	
KHATP-0221-MD-06	CEILING DETAIL,FLOOR JOINERY& SKIRTING DETAIL	A.S	A3	
KHATP-0221-MD-07	LOGO(AT CONFERENCE RM)DETAIL DETAIL	1/20	A3	
KHATP-0221-MD-08	LOGO(AT RECEPTION AREA)DETAIL	1/20	A3	

NOTE:

A.S = AS SHOWN

N.A = NOT AVAILABLE

SITE PHOTO



UNDP building No. 5

1. View of the main elevations and the entrance 2. LAD conference room 3. UN Coordination office 4. Reception and entry hall 5. Front elevation, the entrance area and motor bike parking.

UNDP BUILDING No 5. DETAILED DESIGN 2018-04-09



UNDP BUILDING No 5. DETAILED DESIGN 2018-04-09

DETAIL DRAWING PACKAGE





THE ROOM
DESIGN STUDIO BY MURAYA

Architecture | Interior Design

Tel: 023 993 620
www.theroomds.com

คำกล่าว:

เอกสารนี้ใช้เพื่อวัตถุประสงค์ในการให้ข้อมูลเท่านั้น ไม่สามารถนำมาใช้ในการก่อสร้างหรือการดำเนินงานอื่นใดได้โดยไม่ได้รับอนุญาตจากเจ้าของโครงการ

ผู้จัดทำเอกสารนี้เป็นบริษัทเอกชน จำกัดความรับผิดชอบของตนเอง และไม่รับผิดชอบต่อการใช้งานเอกสารนี้โดยบุคคลอื่น

เอกสารนี้เป็นทรัพย์สินของบริษัท และจะยังคงเป็นเช่นนั้นต่อไป

หากมีการแก้ไขเอกสารนี้ จะต้องแจ้งให้ผู้เกี่ยวข้องทราบก่อน

เอกสารนี้เป็นเอกสารที่จัดทำขึ้นโดย บริษัท เดอะรูม ดีไซน์ สตูดิโอ มูรายา

The Room Design Studio by Muraya.

NOTING

This drawing shall not be used for construction unless certified.
Contractor to verify all dimensions of existing works on site before commencing any work or preparing shop drawings.
Do not scale drawings, use written dimensions only.
Measurements in millimeters.
All units in meters.
This drawing is to be read in conjunction with the specifications and conditions of contract.
Its drawing and design are copyright and no portion may be reproduced without the permission of The Room Design Studio by Muraya.

[illegible]

NDP

EXISTING MASTER PLAN


☐ ពេញលេញ/CONCEPT DESIGN

☒ ប្លង់លម្អិត/DETAILED DESIGN

ឈ្មោះ/POSITION	ឈ្មោះ/NAME
អគ្គនាយក/Director:	P.J
នាយកគម្រោង/Project Manager:	P.J
ប្រឆាំង/Checked by:	P.J
ដេញ/Drawn by:	U.D

— — — — —

ចេញផ្សាយ/Issued Date:	មាត្រដ្ឋាន/Scale:
09 APRIL 2018	1/150 (A3)
លេខសម្គាល់/Drawing No:	
KHATP-0221-001	

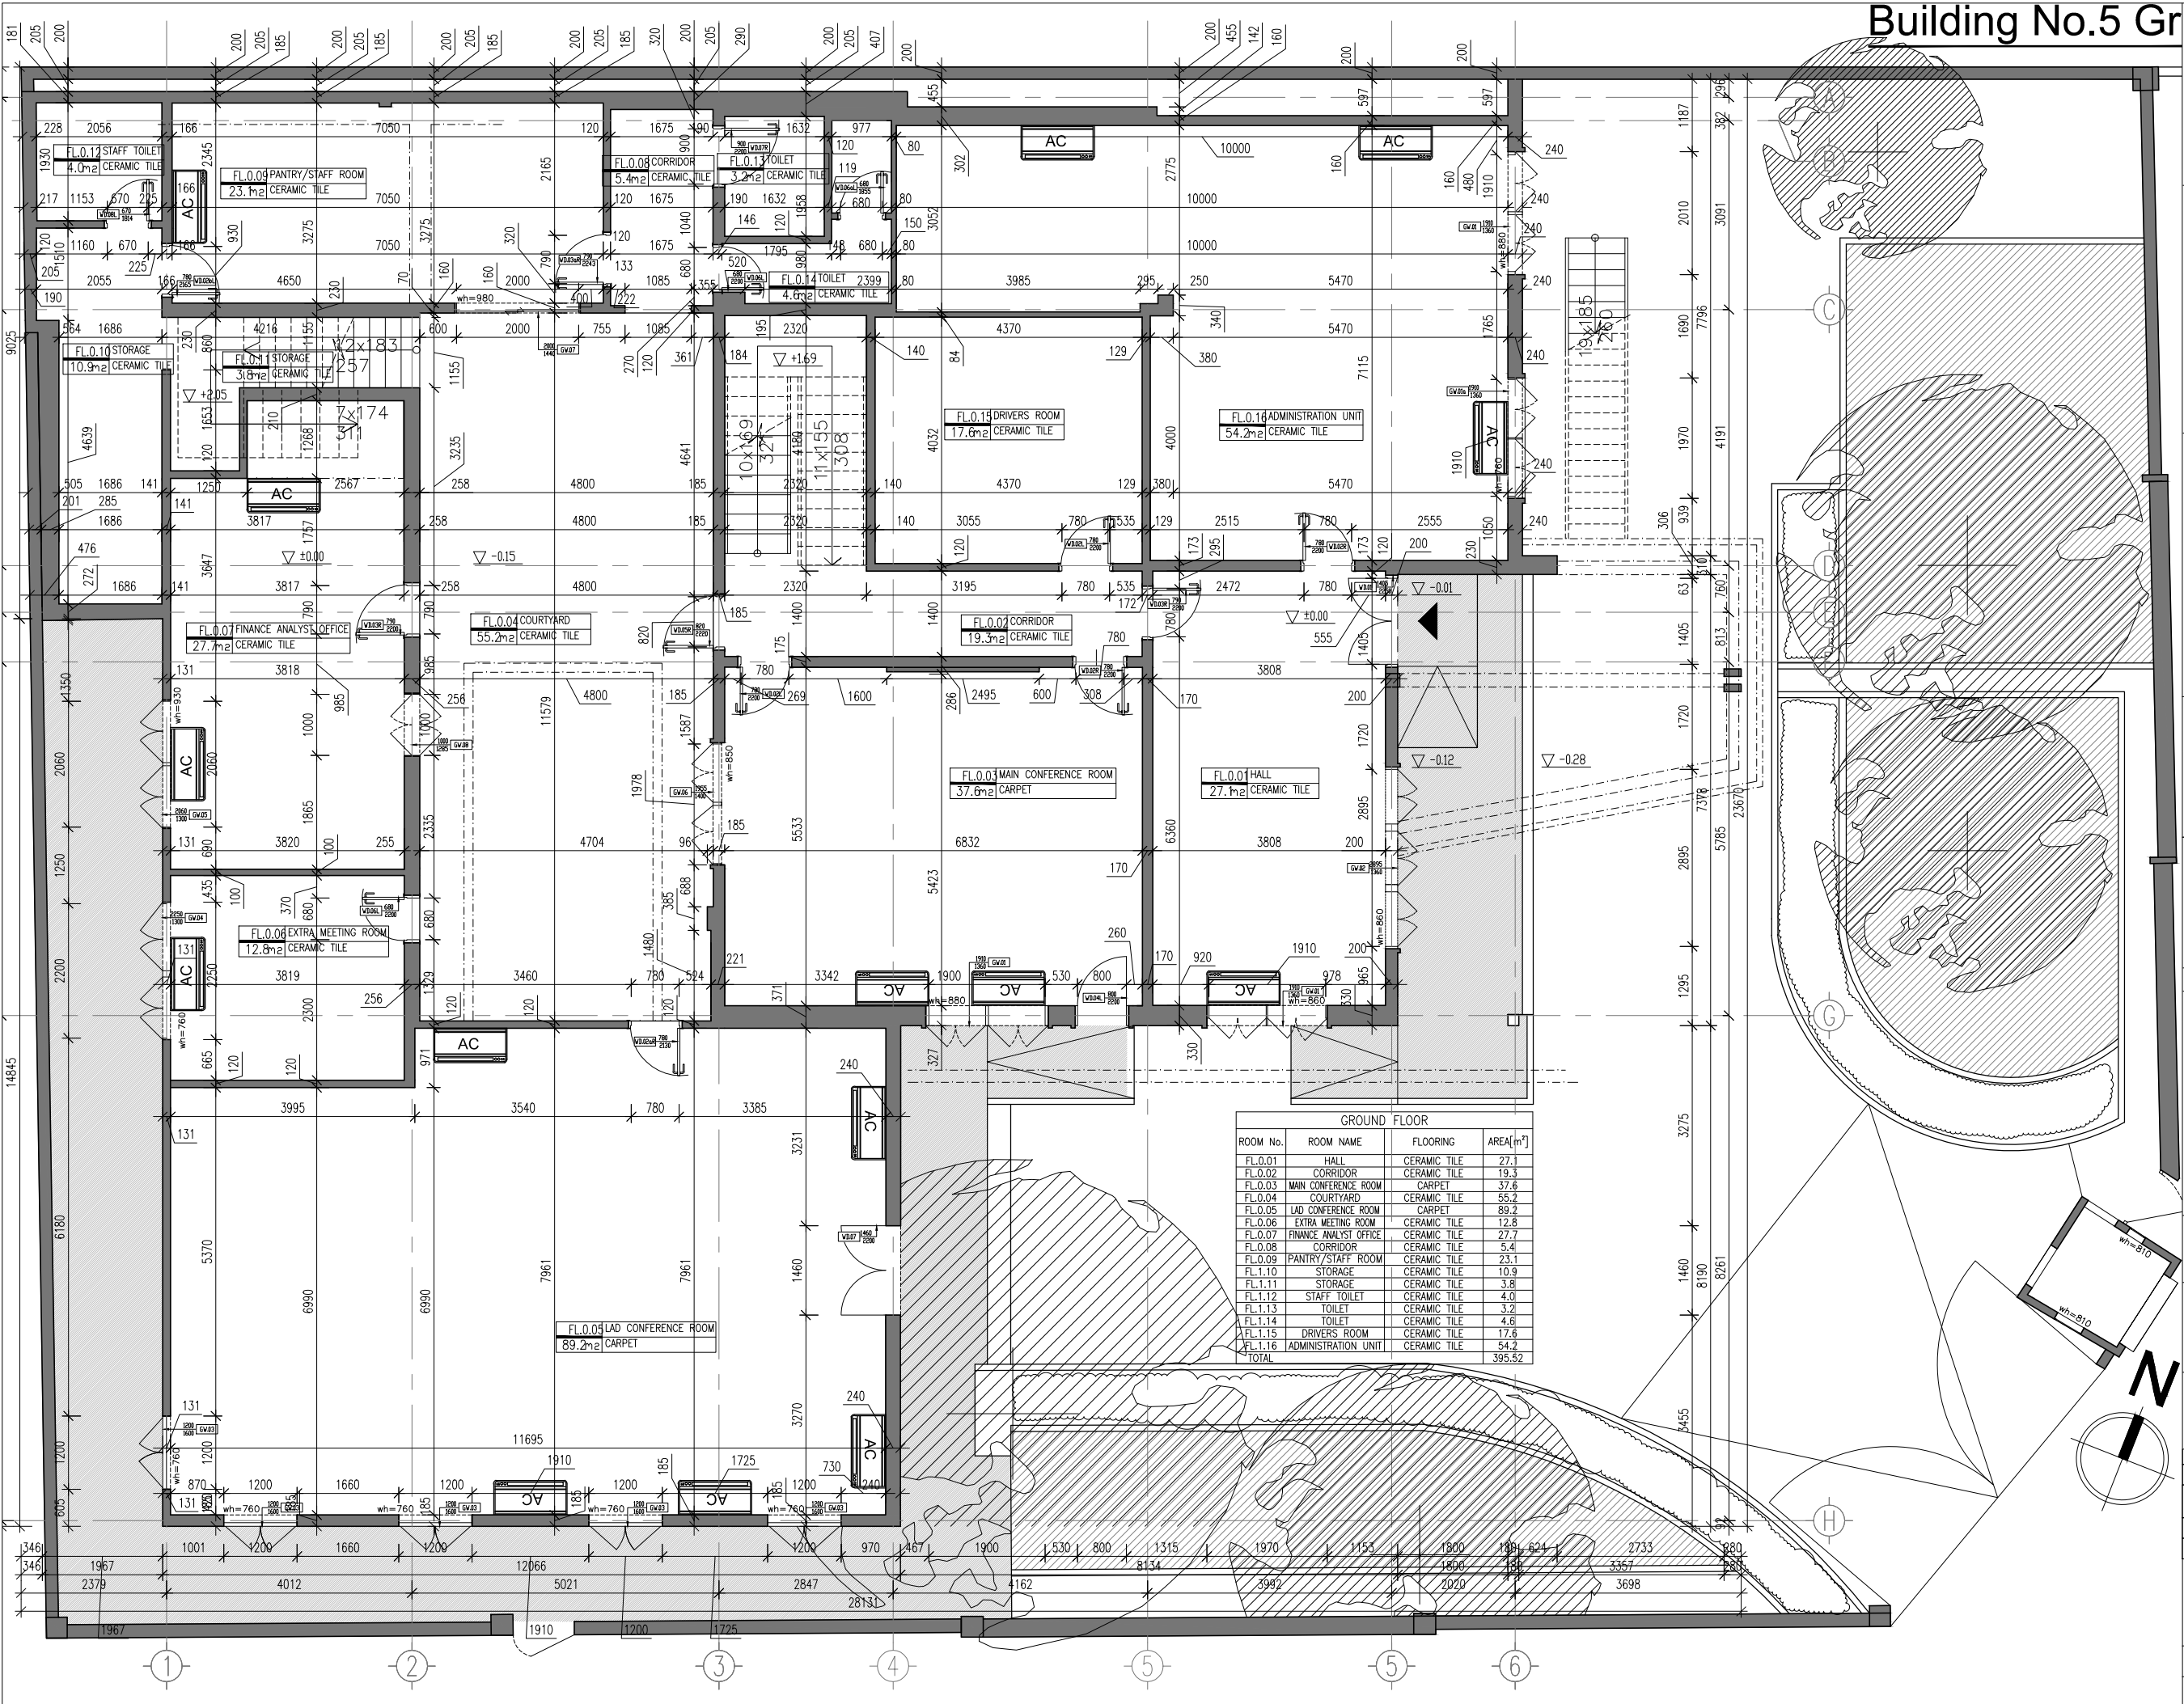

Building No.5 Gr

PROJECT OWNER
UNDP

THE ROOM
DESIGN STUDIO BY MURAYA

Architecture | Interior Design

Tel: 023 993 620
www.theroomsds.com

KEY PLAN / NOTE

- កំណត់សម្គាល់:
- មិនត្រូវប្រើប្រាស់ផែនទីនេះសម្រាប់ការសាងសង់ ឬការកែសម្រួលដោយគ្មានការអនុញ្ញាតពីអ្នករៀបចំផែនទីនេះទេ
 - អ្នកប្រើប្រាស់ត្រូវតែពិនិត្យផែនទីនេះឱ្យបានច្បាស់លាស់ មុនពេលប្រើប្រាស់
 - មិនអាចកាត់ទម្រង់ផែនទីនេះបាន ឬក៏ប្រើប្រាស់ផែនទីនេះដោយមានការកែសម្រួលឡើយ
 - ក្នុងករណីមានការកែសម្រួលផែនទីនេះ អ្នកប្រើប្រាស់ត្រូវតែពិនិត្យផែនទីនេះឱ្យបានច្បាស់លាស់
 - ក្នុងករណីមានការកែសម្រួលផែនទីនេះ អ្នកប្រើប្រាស់ត្រូវតែពិនិត្យផែនទីនេះឱ្យបានច្បាស់លាស់
 - ក្នុងករណីមានការកែសម្រួលផែនទីនេះ អ្នកប្រើប្រាស់ត្រូវតែពិនិត្យផែនទីនេះឱ្យបានច្បាស់លាស់
- WARNING
- This drawing shall not be used for construction unless certified.
 - Contractor to verify all dimensions of existing works on site before commencing any work or preparing shop drawings.
 - Do not scale drawings, use written dimensions only.
 - All measurements in millimeters.
 - All levels in meters.
 - This drawing is to be read in conjunction with the specifications and conditions of contract.
 - This drawing and design are copyright and no portion may be produced without the permission of The Room Design Studio By Muraya.

REVISIONS:	
H	
G	
F	
E	
D	
C	
B	
A	
REF:	កំណត់សម្គាល់/Remarks
	Date

ឈ្មោះគម្រោង/Project Title:
UNDP

ឈ្មោះរូប/Drawing Title:
GROUND FLOOR EXISTING LAYOUT

ស្ថាបត្យករ/Architect/Phase:

● គំនិត/CONCEPT DESIGN
● ប្រតិបត្តិ/DETAILED DESIGN

អ្នករៀបចំ/POSITION	ឈ្មោះ/NAME
នាយក/Director:	P.J
ប្រធានការងារ/Project Manager:	P.J
ត្រួតពិនិត្យ/Checked by:	P.J
គូររូប/Drawn by:	UD

ឈ្មោះ/Issued for:

ចេញផ្សាយ/Issued Date:
09 APRIL 2018

មាត្រដ្ឋាន/Scale:
1/100 (A3)

លេខផ្សាយ/Drawing No:
KHATP-0221-002a

PROJECT OWNER
UNDP



KEY PLAN / NOTE

“กัปดัลลံสาคา”

- ชื่อแปลว่า “ลูกคนดั่ง” ประดิษฐานทางผนังด้านขวา ประตูทางออกทางประตูทางออก
- มีลักษณะเป็นรูปปั้นคนยืนอยู่หน้าประตูทางออก
- ชื่อภาษาบาลีว่า “กัปดัลลံสาคา” แปลว่า “ลูกคนดั่ง” ประดิษฐานทางผนังด้านขวา ประตูทางออกทางประตูทางออก

เมื่อผู้ชมได้ดูภาพแล้ว

- ภาชนะที่ประดิษฐานอยู่หน้าประตูทางออก
- ภาชนะที่ประดิษฐานอยู่หน้าประตูทางออก
- ภาชนะที่ประดิษฐานอยู่หน้าประตูทางออก

การออกแบบโดย **The Room Design Studio By Muraya.**

WARNING

- This drawing shall not be used for construction unless certified.
- Contractor to verify all dimensions of existing works on site before commencing any work or preparing shop drawings.
- Do not scale drawings, use written dimensions only.
- All measurements in millimeters.
- All levels in meters.
- This drawing is to be read in conjunction with the specifications and conditions of contract.
- This drawing and design are copyright and no portion may be produced without the permission of The Room Design Studio By Muraya.

REVISIONS:

H		
G		
F		
E		
D		
C		
B		
A		
REF	ลักษณะตัวอย่าง/Remarks	Date

 
ឈ្មោះគម្រោង/Project Title:

UNDP

Drawing Title:

FIRST FLOOR EXISTING LAYOUT

ចំណាត់ការជំនួស/Phase:




អ្នកបំពេញ/POSITION	ឈ្មោះ/NAME
នាយក/Director:	P.J
ប្រធានសិក្សាគ្រូបង្រៀន/ /Project Manager:	P.J
ពិនិត្យ/Checked by:	P.J
គូររូប/Drawn by:	U.D

បញ្ជី/Issued for:

ចេញថ្ងៃ/Issued Date: 09 APRIL 2018	មាត្រដ្ឋាន/Scale: 1/100 (A3)
---------------------------------------	---------------------------------

លេខស្និត/Drawing No:

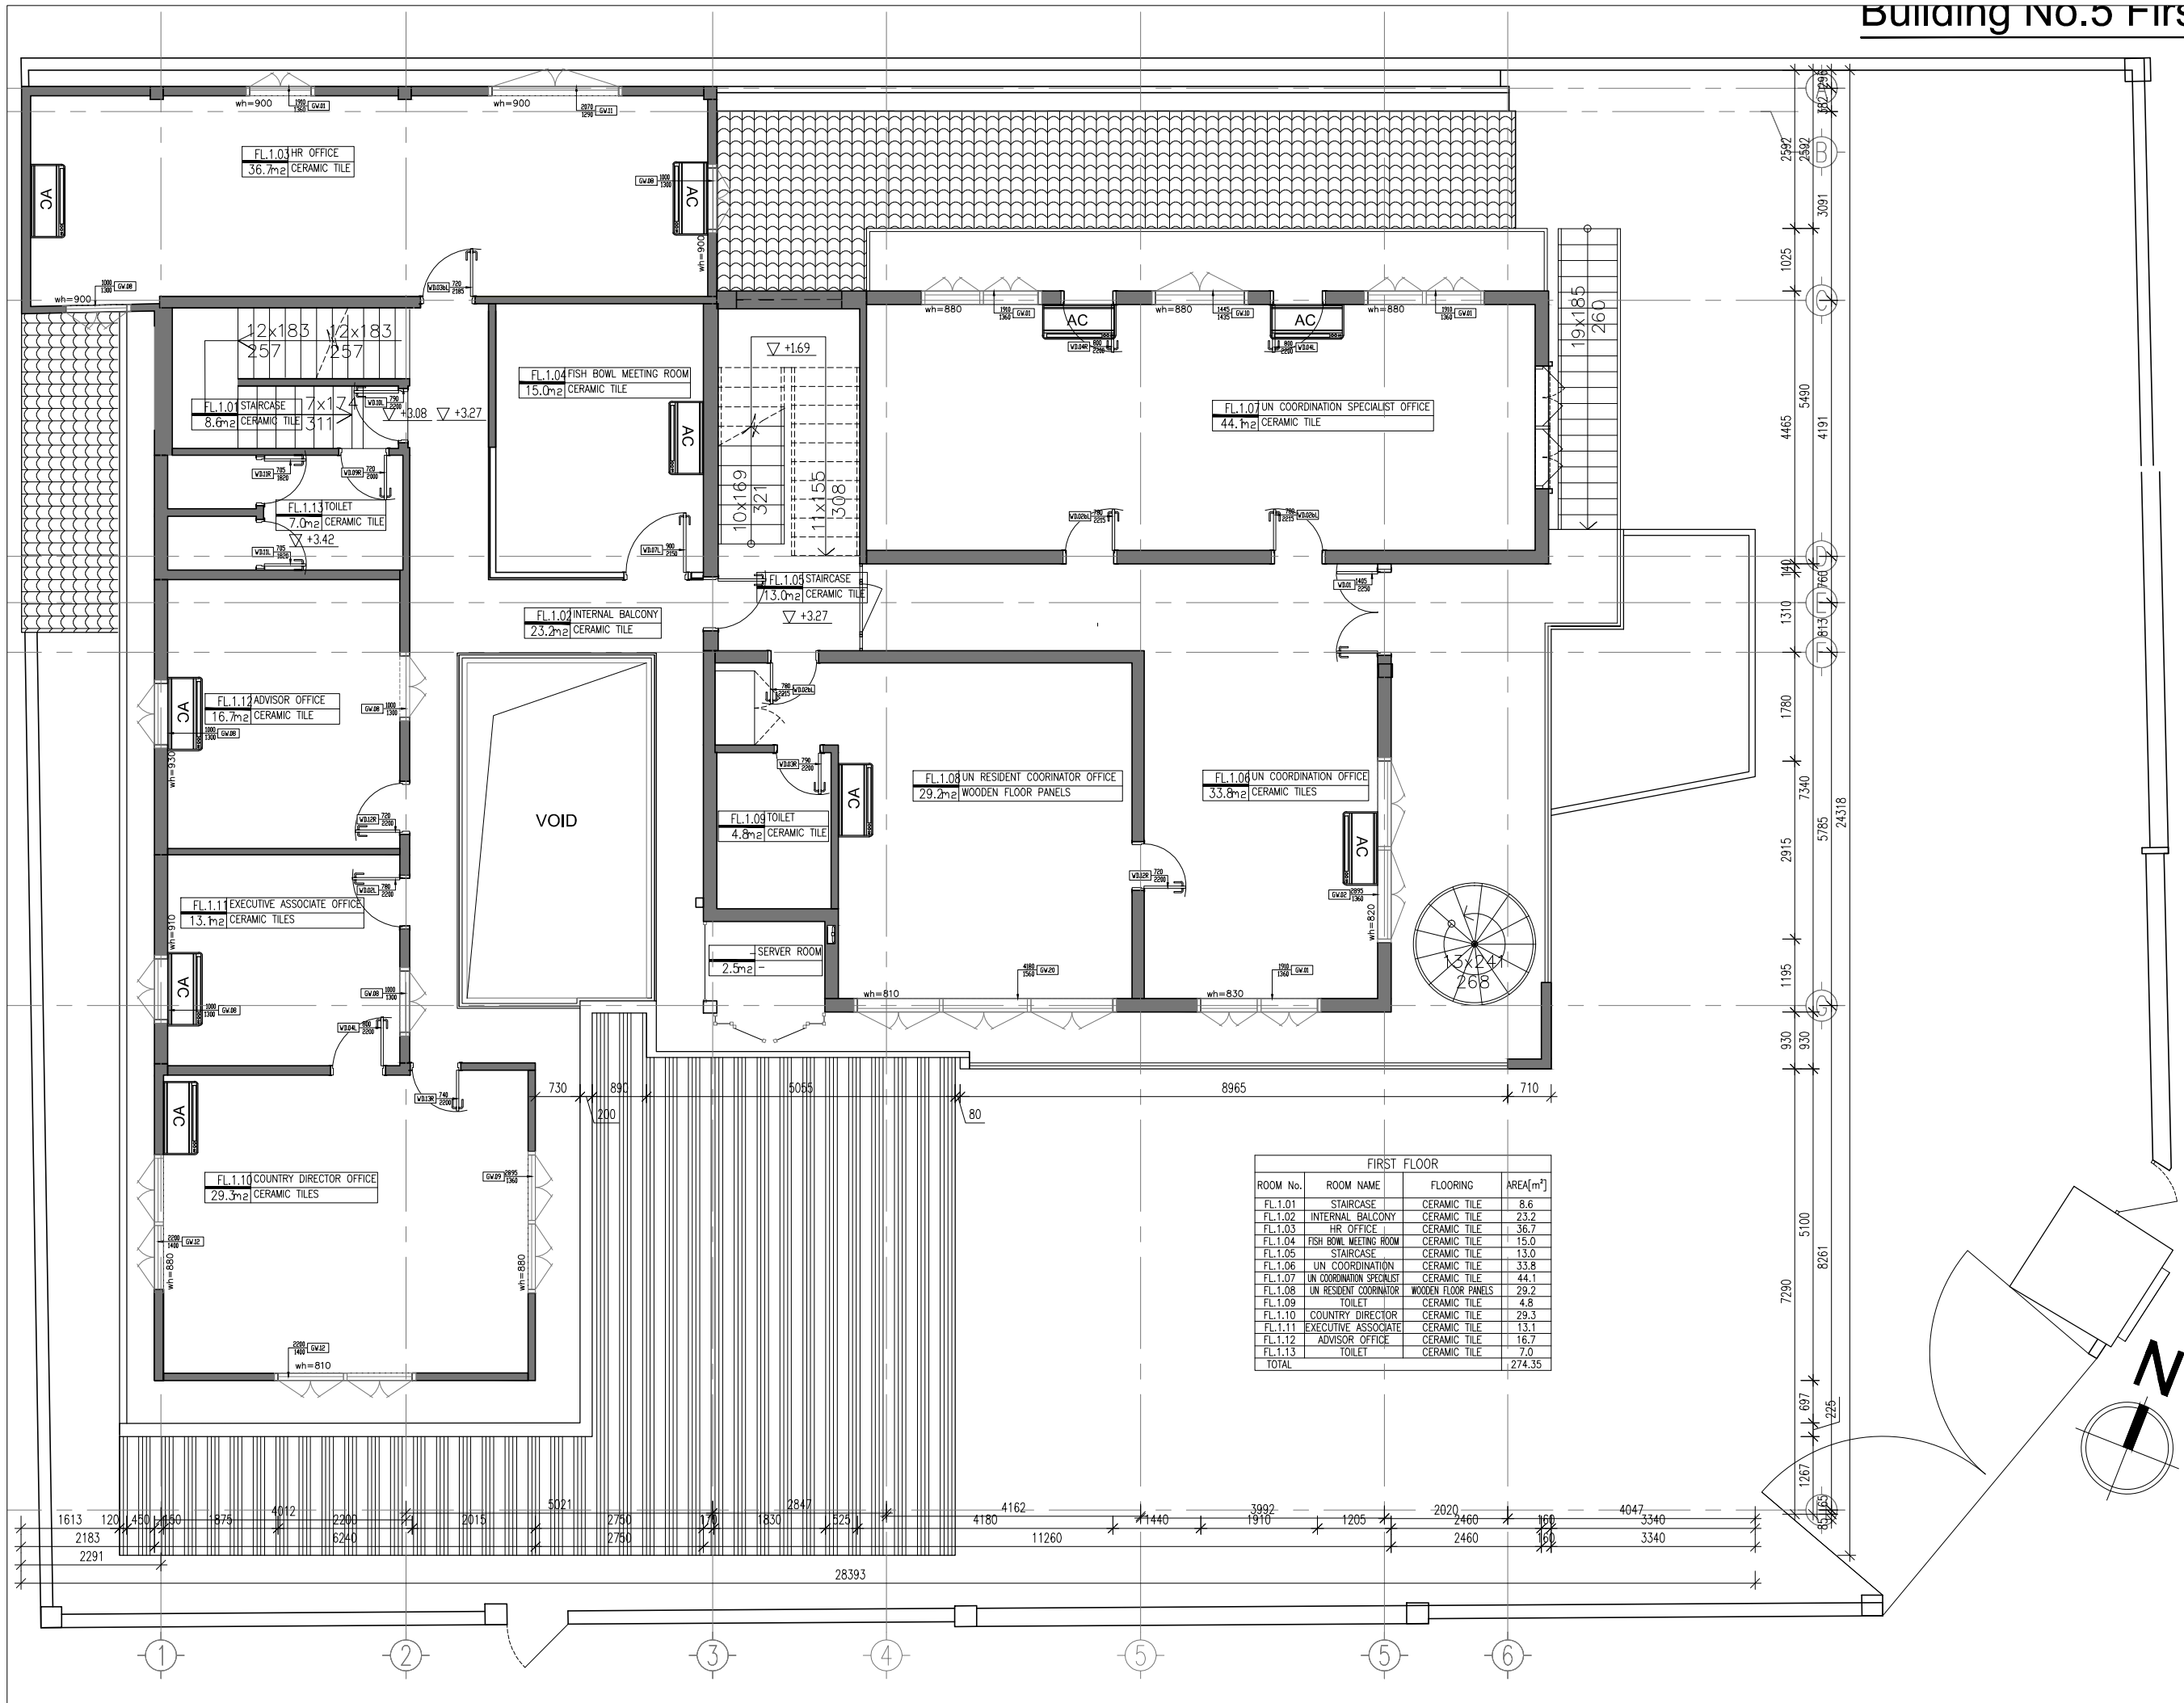



KEY PLAN / NOTE

កំណត់សំគាល់:
- មិនត្រូវប្រើប្រាស់ផែនទីនេះសម្រាប់ការសាងសង់ ឬការកែសម្រួលទីតាំងណាមួយ
- អ្នកកសាងត្រូវត្រួតពិនិត្យទីតាំងនេះមុនពេលចាប់ផ្តើមការងារ
- ប្រសិនបើមានការកែសម្រួលទីតាំងណាមួយ ត្រូវរាយការណ៍ជាលិខិតដល់អ្នករៀបចំផែនទី
- រាល់ការកែសម្រួលទីតាំងណាមួយ ត្រូវតែមានការអនុញ្ញាតពីអ្នករៀបចំផែនទី
- ប្រសិនបើមានការកែសម្រួលទីតាំងណាមួយ ត្រូវតែមានការអនុញ្ញាតពីអ្នករៀបចំផែនទី
- ផែនទីនេះត្រូវបានរៀបចំឡើងដោយប្រើប្រាស់ទិន្នន័យពីការវាស់វែង ឬការវាស់វែងដោយប្រើប្រាស់
ការវាស់វែងដោយប្រើប្រាស់ **The Room Design Studio By Muraya.**

WARNING
- This drawing shall not be used for construction unless certified.
- Contractor to verify all dimensions of existing works on site before commencing any work or preparing shop drawings.
- Do not scale drawings, use written dimensions only.
- All measurements in millimeters.
- All levels in meters.
- This drawing is to be read in conjunction with the specifications and conditions of contract.
- This drawing and design are copyright and no portion may be produced without the permission of The Room Design Studio By Muraya.

REVISIONS:

REV	DESCRIPTION	DATE
H		
G		
F		
E		
D		
C		
B		
A		
REF	កំណត់សំគាល់/Remarks	Date

ឈ្មោះគម្រោង/Project Title:

UNDP

ឈ្មោះគម្រោង/Drawing Title:

SECOND FLOOR EXISTING LAYOUT

ស្ថានភាពគម្រោង/Phase:


- ☐ គម្រោងគិត/CONCEPT DESIGN
☒ គម្រោងលម្អិត/DETAILED DESIGN

POSITION	NAME
អគ្គនាយក/Director:	P.J
ប្រធានគម្រោង/Project Manager:	P.J
ត្រួតពិនិត្យ/Checked by:	P.J
ទាញរូប/Drawn by:	UD

ឈ្មោះ/Issued for:

ចេញផ្សាយ/Issued Date: 09 APRIL 2018
មាត្រដ្ឋាន/Scale: 1/100 (A3)

លេខគម្រោង/Drawing No: KHATP-0221-002c

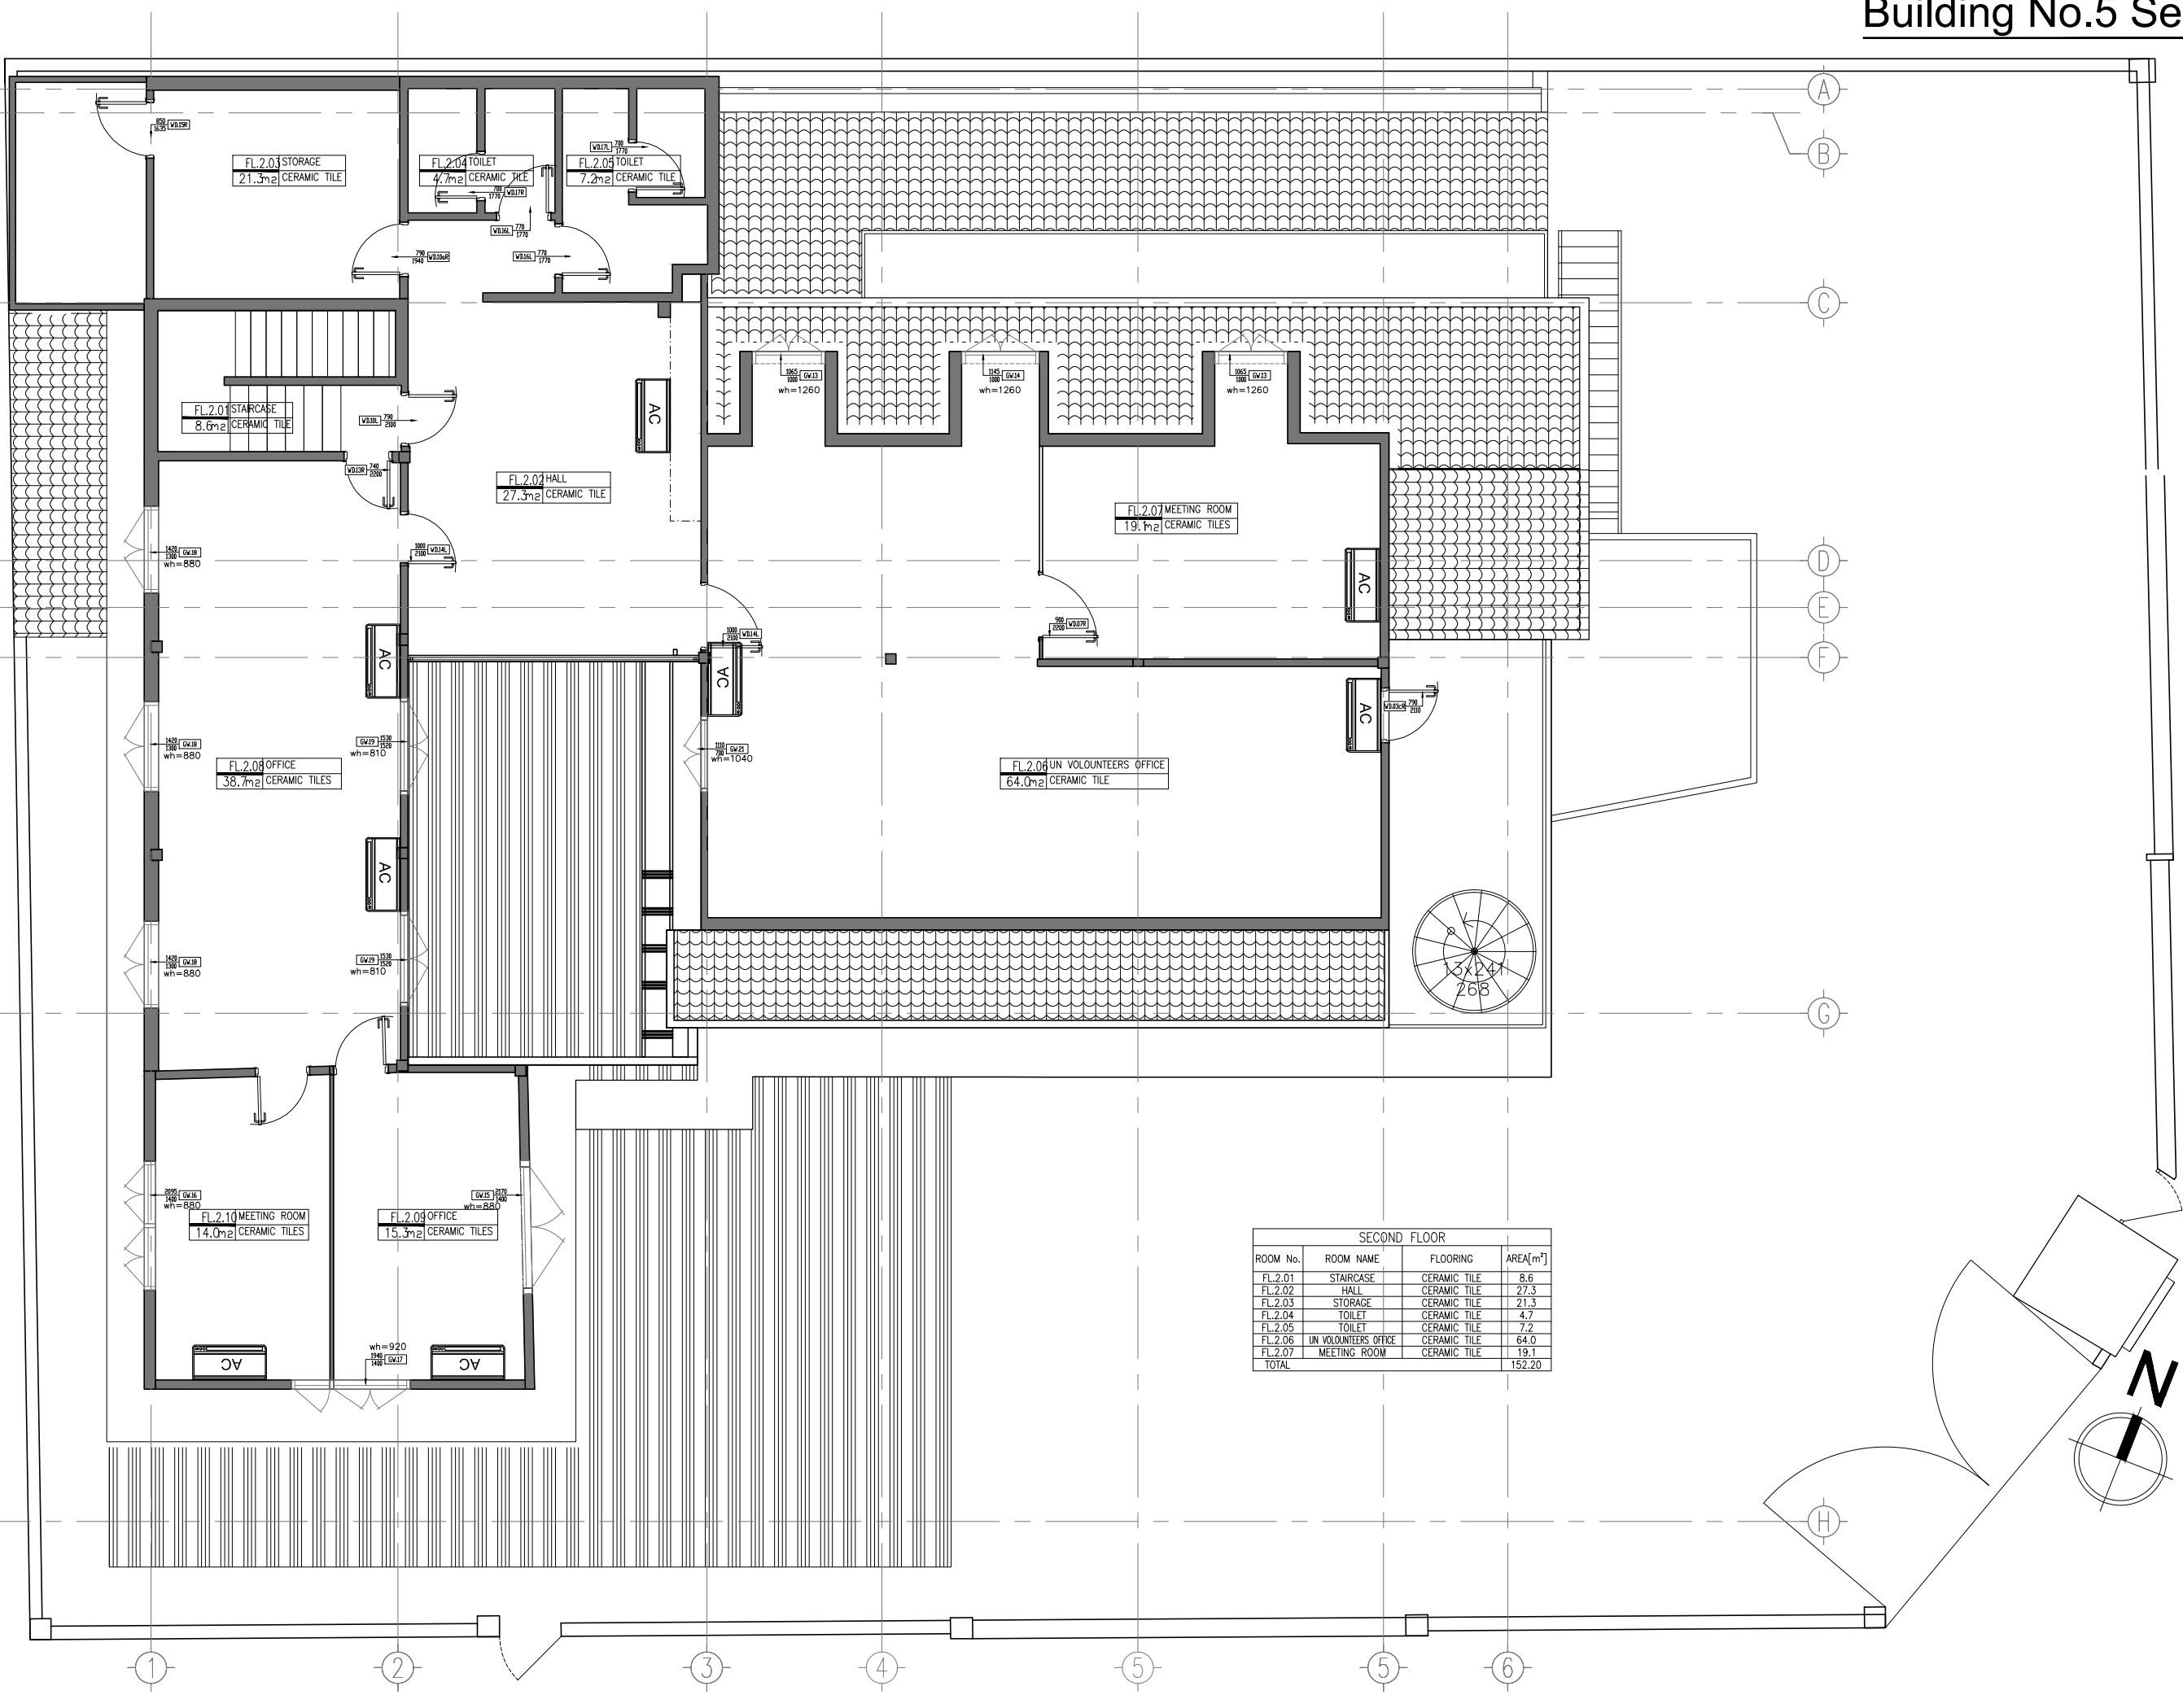

SECOND FLOOR			
ROOM No.	ROOM NAME	FLOORING	AREA[m ²]
FL.2.01	STAIRCASE	CERAMIC TILE	8.6
FL.2.02	HALL	CERAMIC TILE	27.3
FL.2.03	STORAGE	CERAMIC TILE	21.3
FL.2.04	TOILET	CERAMIC TILE	4.7
FL.2.05	TOILET	CERAMIC TILE	7.2
FL.2.06	UN VOLUNTEERS OFFICE	CERAMIC TILE	64.0
FL.2.07	MEETING ROOM	CERAMIC TILE	19.1
TOTAL			152.20



PROJECT OWNER

UNDP

THE ROOM

DESIGN STUDIO BY MURAYA

Architecture | Interior Design

Tel: 023 993 620

www.theroomds.com

KEY PLAN / NOTE

- កំណត់សំគាល់:
- មិនត្រូវប្រើប្រាស់ប្លង់នេះសម្រាប់ការសាងសង់បាន ពុំត្រូវតែមានការអនុញ្ញាត
 - អ្នកកាន់ប្លង់ត្រូវតែប្រាកដថាប្លង់នេះត្រូវបានប្រើប្រាស់តាមការបញ្ជាក់ មុនពេលបើកការសាងសង់
 - ប្រសិនបើមានការកែប្រែប្លង់ ឬប្រើប្រាស់ប្លង់ដែលមានលក្ខណៈប្លង់ប្លង់ ឬប្រើប្រាស់ប្លង់ដែលមានលក្ខណៈប្លង់ប្លង់
 - រាល់ការកែប្រែប្លង់ត្រូវបានប្រើប្រាស់តាមការបញ្ជាក់
 - រាល់ការកែប្រែប្លង់ត្រូវបានប្រើប្រាស់តាមការបញ្ជាក់
 - ប្រសិនបើមានការកែប្រែប្លង់ ឬប្រើប្រាស់ប្លង់ដែលមានលក្ខណៈប្លង់ប្លង់ ឬប្រើប្រាស់ប្លង់ដែលមានលក្ខណៈប្លង់ប្លង់
 - ប្រសិនបើមានការកែប្រែប្លង់ ឬប្រើប្រាស់ប្លង់ដែលមានលក្ខណៈប្លង់ប្លង់ ឬប្រើប្រាស់ប្លង់ដែលមានលក្ខណៈប្លង់ប្លង់
- The Room Design Studio By Muraya.

WARNING

- This drawing shall not be used for construction unless certified.
- Contractor to verify all dimensions of existing works on site before commencing any work or preparing shop drawings.
- Do not scale drawings, use written dimensions only.
- All measurements in millimeters.
- All levels in meters.
- This drawing is to be read in conjunction with the specifications and conditions of contract.
- This drawing and design are copyright and no portion may be produced without the permission of The Room Design Studio By Muraya.

REVISIONS:		
H		
G		
F		
E		
D		
C		
B		
A		
REF	កំណត់សំគាល់/Remarks	Date

ឈ្មោះគម្រោង/Project Title:

UNDP

ឈ្មោះប្រភេទគម្រោង/Drawing Title:

EXISTING ELEVATION FRONT VIEW

ស្ថានភាពគម្រោង/Phase:


☒ ប្រភេទគម្រោង/CONCEPT DESIGN

☐ ប្រភេទគម្រោង/DETAILED DESIGN

ប្រភេទគម្រោង/POSITION	ឈ្មោះ/NAME
អគ្គនាយក/Director:	P.J
ប្រធានក្រុមគម្រោង/Project Manager:	P.J
ត្រួតពិនិត្យ/Checked by:	P.J
គូររូប/Drawn by:	D.L

ឈ្មោះ/Issued for:

ចេញផ្សាយ/Issued Date:	កាលបរិច្ឆេទ/Scale:
09 APRIL 2018	1/100 (A3)
លេខគម្រោង/Drawing No:	
KHATP-0221-003A	

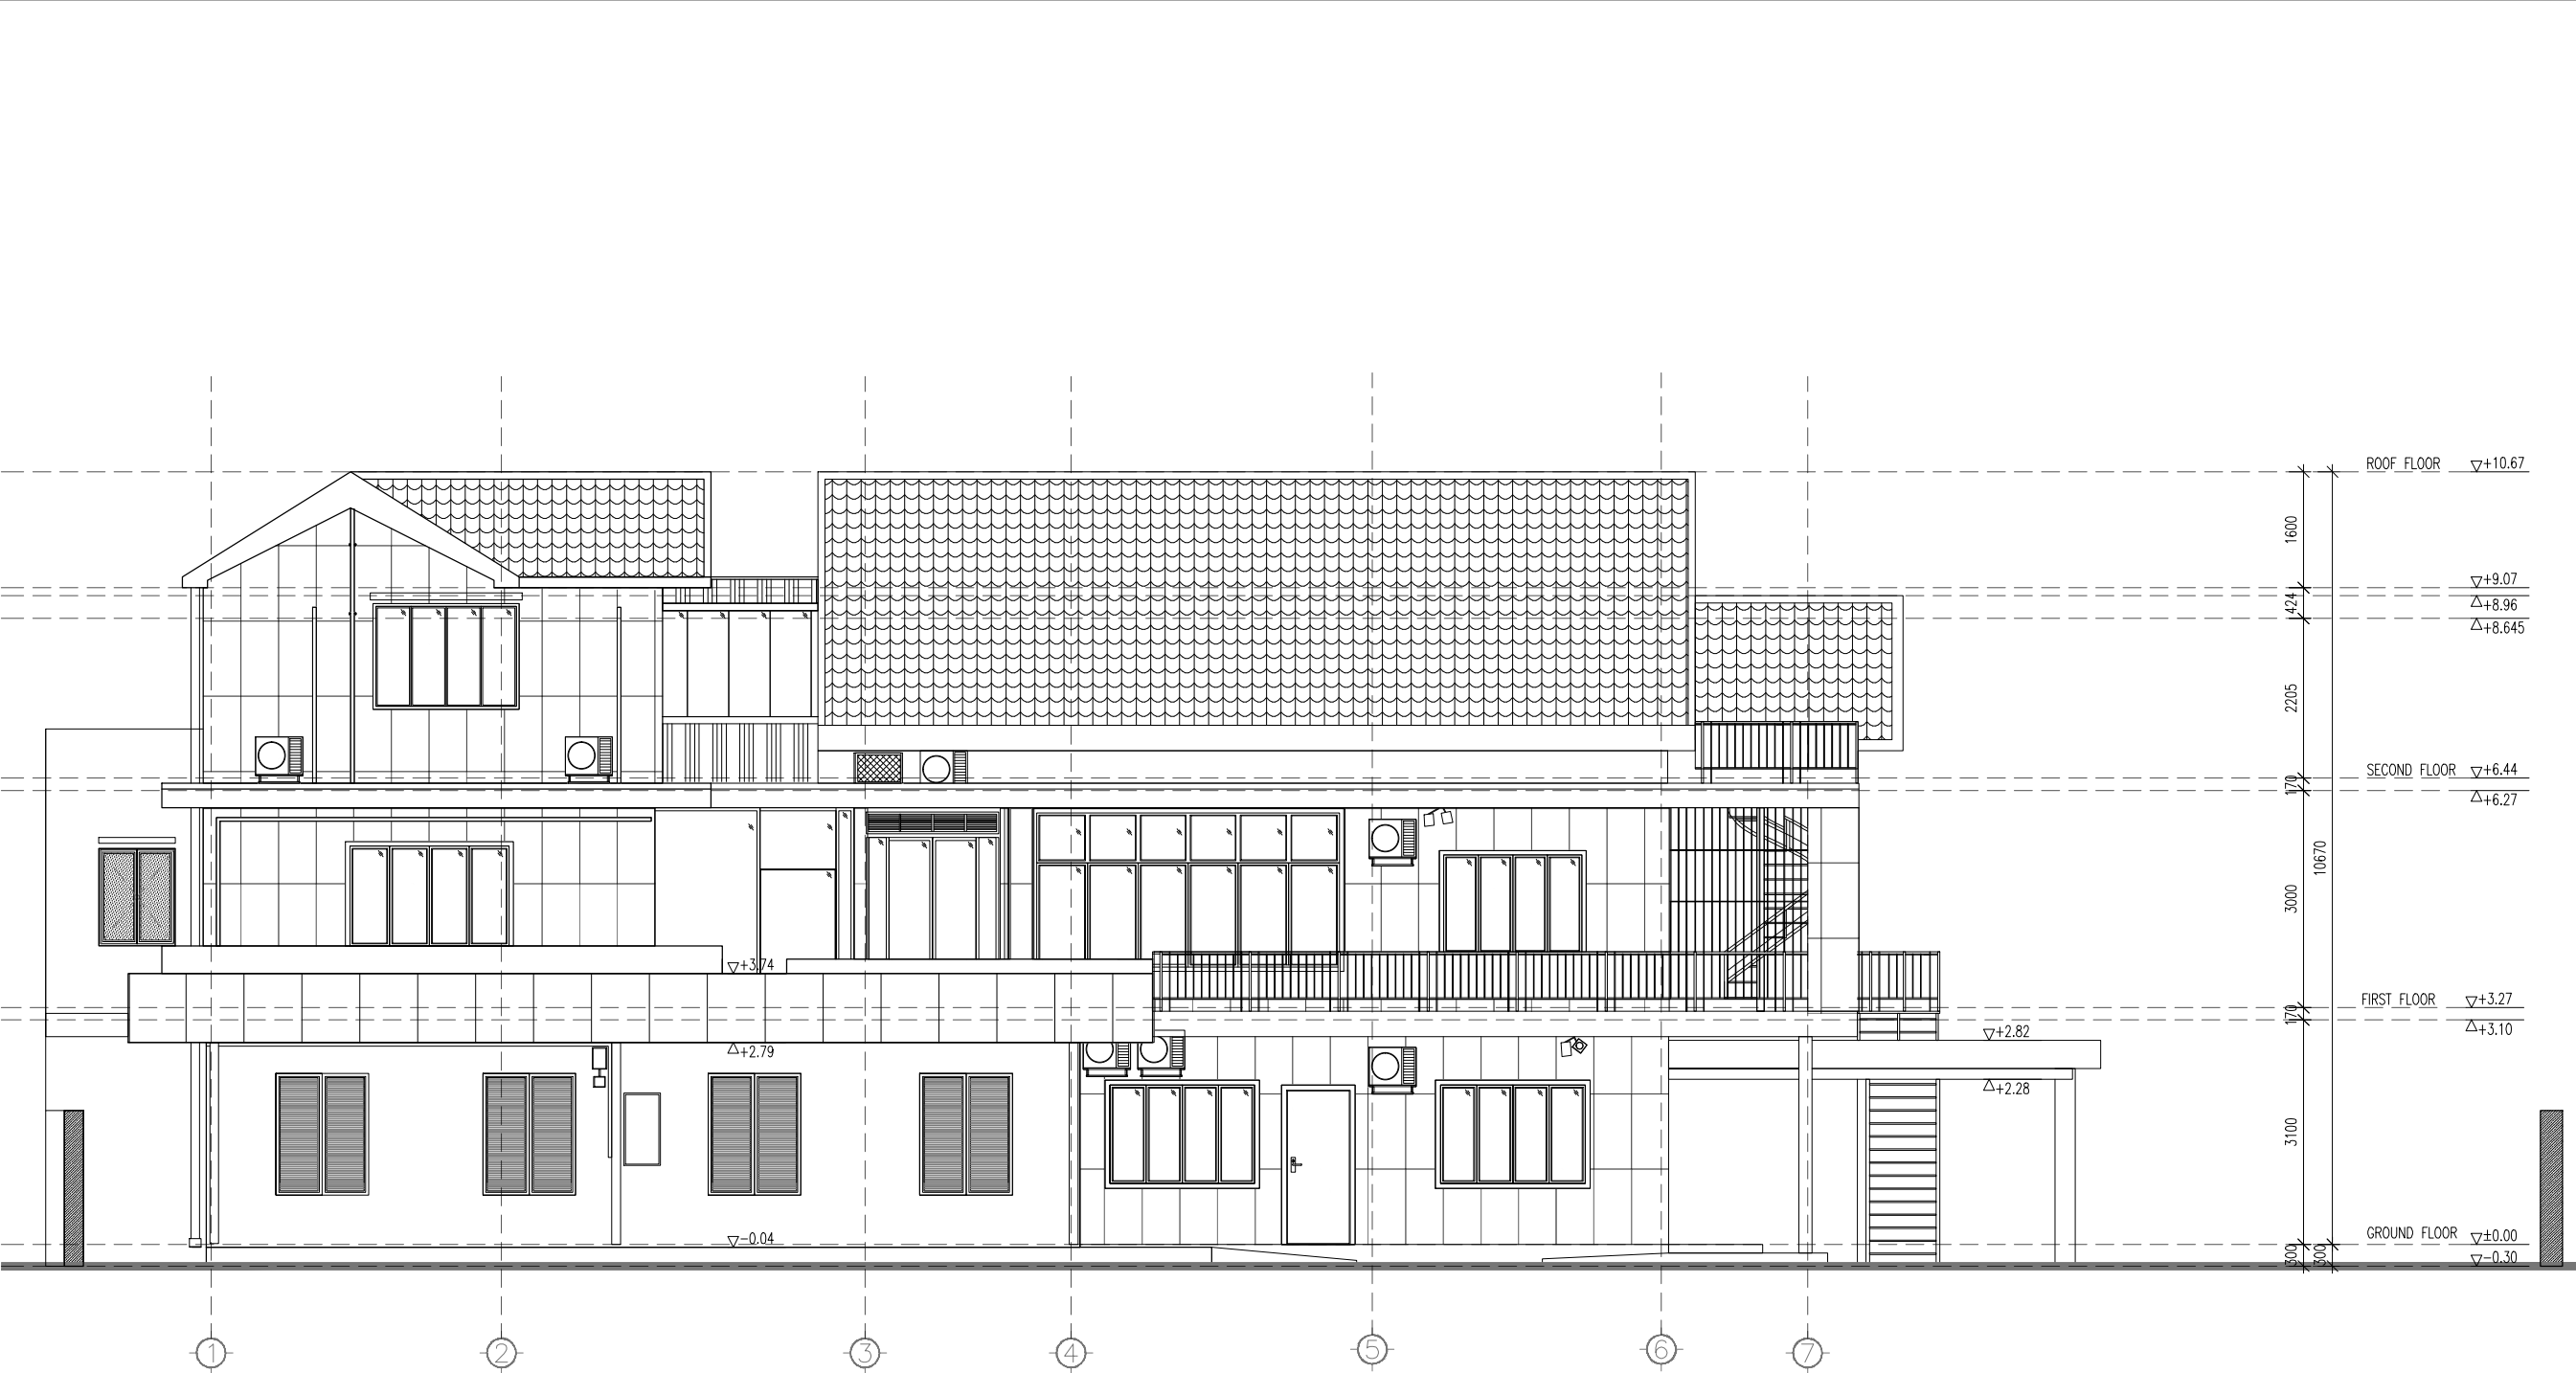

2 SOUTH ELEVATION (SIDE VIEW)
1/100

PROJECT OWNER
UNDP

THE ROOM

DESIGN STUDIO BY MURAYA

Architecture | Interior Design

Tel: 023 993 620
www.theroomds.com

KEY PLAN / NOTE

កំណត់សម្គាល់:

- មិនត្រូវប្រើប្រាស់ផែនទីនេះសម្រាប់ការសាងសង់ឡើយ ព្រោះវាមិនមែនជាផែនទីសម្រាប់ការសាងសង់ឡើយ
- អ្នកសាងសង់ត្រូវតែប្រើប្រាស់ផែនទីនេះតាមការណែនាំរបស់អ្នកសាងសង់ មុនពេលចាប់ផ្តើមការសាងសង់
- មិនអាចកាត់បន្ថយទំហំឬបន្ថែម ឬប្រែប្រួលទំហំឬបន្ថែមបានឡើយ ព្រោះវាមិនមែនជាផែនទីសម្រាប់ការសាងសង់ឡើយ
- មិនមែនជាផែនទីសម្រាប់ការសាងសង់ឡើយ
- រាល់ការកាត់បន្ថយទំហំឬបន្ថែម ឬប្រែប្រួលទំហំឬបន្ថែម ត្រូវតែមានការអនុញ្ញាតពីអ្នកសាងសង់
- រាល់ការកាត់បន្ថយទំហំឬបន្ថែម ឬប្រែប្រួលទំហំឬបន្ថែម ត្រូវតែមានការអនុញ្ញាតពីអ្នកសាងសង់
- មិនអាចកាត់បន្ថយទំហំឬបន្ថែម ឬប្រែប្រួលទំហំឬបន្ថែមបានឡើយ ព្រោះវាមិនមែនជាផែនទីសម្រាប់ការសាងសង់ឡើយ
- មិនអាចកាត់បន្ថយទំហំឬបន្ថែម ឬប្រែប្រួលទំហំឬបន្ថែមបានឡើយ ព្រោះវាមិនមែនជាផែនទីសម្រាប់ការសាងសង់ឡើយ

WARNING

- This drawing shall not be used for construction unless certified.
- Contractor to verify all dimensions of existing works on site before commencing any work or preparing shop drawings.
- Do not scale drawings, use written dimensions only.
- All measurements in millimeters.
- All levels in meters.
- This drawing is to be read in conjunction with the specifications and conditions of contract.
- This drawing and design are copyright and no portion may be produced without the permission of The Room Design Studio By Muraya.

REVISIONS:

H		
G		
F		
E		
D		
C		
B		
A		

REF	កំណត់សម្គាល់/Remarks	Date
-----	----------------------	------

ឈ្មោះគម្រោង/Project Title:

UNDP

ឈ្មោះផែនទី/Drawing Title:

EXISTING ELEVATION
SOUTH ELEVATION (SIDE VIEW)

ចំណាត់ការគម្រោង/Phase:

គម្រោងគិត/CONCEPT DESIGN

ប្លង់សម្រាប់ការសាងសង់/DETAILED DESIGN

ប្រធានគម្រោង/DIRECTOR	ឈ្មោះ/NAME
សមាជិក/Director:	P.J
ប្រធានគម្រោង/Project Manager:	P.J
ត្រួតពិនិត្យ/Checked by:	P.J
គូររូប/Drawn by:	D.L

ឈ្មោះ/Issued for:

ចេញផ្សាយ/Issued Date:	ចេញផ្សាយ/Scale:
09 APRIL 2018	1/100 (A3)
លេខផ្សាយ/Drawing No:	
KHATP-0221-003B	



Tel: 023 993 620
www.theroomds.com


កំណត់សំគាល់:

- WARNING**
- This drawing shall not be used for construction unless certified.
 - Contractor to verify all dimensions of existing works on site before commencing any work or preparing shop drawings.
 - Do not scale drawings, use written dimensions only.
 - **All measurements in millimeters.**
 - All levels in meters.
 - This drawing is to be read in conjunction with the specifications and conditions of contract.
 - This drawing and design are copyright and no portion may be produced without the permission of **The Room Design Studio By Murya.**

H		
G		
F		
E		
D		
C		
B		
A		
REF.	កាលបរិច្ឆេទ/Remarks	Date

លេខ/ Drawing No:
KHATP-0221-003C



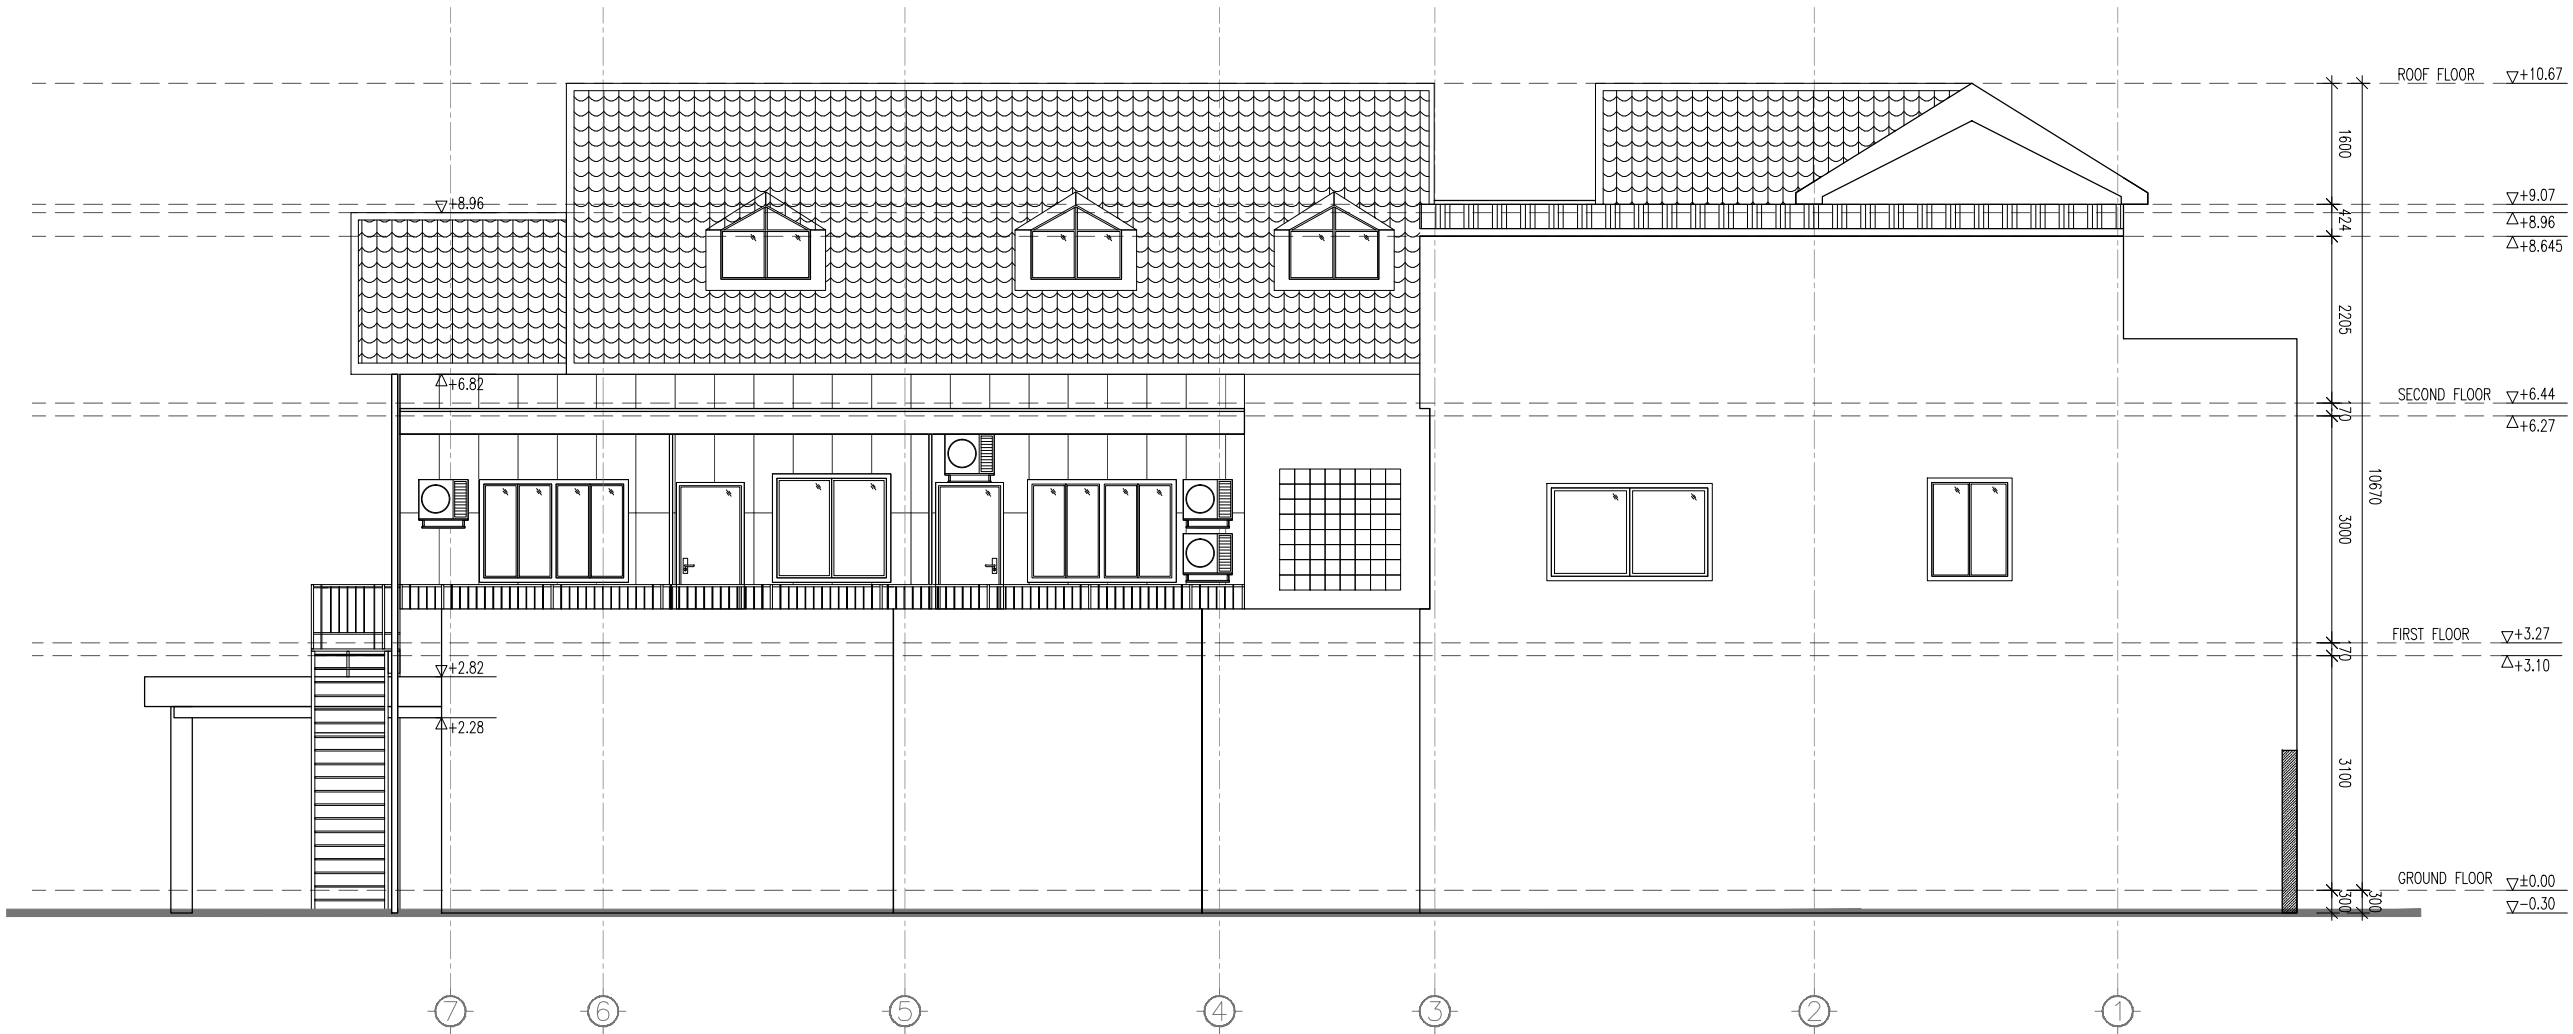

4 NORTH ELEVATION (SIDE VIEW)
1/100

PROJECT OWNER
UNDP

THE ROOM

DESIGN STUDIO BY MURAYA

Architecture | Interior Design

Tel: 023 993 620
www.theroomds.com

KEY PLAN / NOTE

កំណត់សំគាល់:

- មិនត្រូវប្រើប្រាស់ផែនទីការសាងសង់ជូន ពួកគេតែម្នាក់ឯងទេ ពួកគេត្រូវតែមានការអនុញ្ញាត
- អ្នកសាងសង់ត្រូវតែប្រើប្រាស់ផែនទីការសាងសង់ មុនពេលចាប់ផ្តើមការសាងសង់
- មិនអាចកាត់បន្ថយទំហំប្លង់ ឬប្រែប្រួលទំហំប្លង់បាន ប្រសិនបើមានការអនុញ្ញាតពីអ្នកសាងសង់
- មិនអនុញ្ញាតឱ្យប្រើប្រាស់
- រាល់ការកាត់បន្ថយទំហំប្លង់ ឬប្រែប្រួលទំហំប្លង់ ត្រូវតែមានការអនុញ្ញាតពីអ្នកសាងសង់
- រាល់ការកាត់បន្ថយទំហំប្លង់ ឬប្រែប្រួលទំហំប្លង់ ត្រូវតែមានការអនុញ្ញាតពីអ្នកសាងសង់
- ប្រសិនបើមានការកាត់បន្ថយទំហំប្លង់ ឬប្រែប្រួលទំហំប្លង់ ត្រូវតែមានការអនុញ្ញាតពីអ្នកសាងសង់
- ផែនទីការសាងសង់ត្រូវតែមានការអនុញ្ញាតពីអ្នកសាងសង់

WARNING

- This drawing shall not be used for construction unless certified.
- Contractor to verify all dimensions of existing works on site before commencing any work or preparing shop drawings.
- Do not scale drawings, use written dimensions only.
- All measurements in millimeters.
- All levels in meters.
- This drawing is to be read in conjunction with the specifications and conditions of contract.
- This drawing and design are copyright and no portion may be produced without the permission of The Room Design Studio By Muraya.

REVISIONS:

H		
G		
F		
E		
D		
C		
B		
A		

REF: កំណត់សំគាល់/RemarksDate

ឈ្មោះគម្រោង/Project Title:
UNDP

ឈ្មោះរូប/Drawing Title:
EXISTING ELEVATION
NORTH ELEVATION (SIDE VIEW)

ចំណាត់ការគម្រោង/Phase:
☐ ប្រភេទគំនិត/CONCEPT DESIGN
☒ ប្រភេទគំនិត/DETAILED DESIGN

ប្រភេទគំនិត/POSITION	ឈ្មោះ/NAME
អគ្គនាយក/Director:	P.J
ប្រធានក្រុមគម្រោង/Project Manager:	P.J
ត្រួតពិនិត្យ/Checked by:	P.J
គូររូប/Drawn by:	D.L

ឈ្មោះ/Issued for:

ចេញផ្សាយ/Issued Date: 09 APRIL 2018	មាត្រដ្ឋាន/Scale: 1/100 (A3)
លេខគម្រោង/Drawing No: KHATP-0221-003D	



កំណត់សម្គាល់:
- មិនត្រូវប្រើប្រាស់ផែនទីនេះសម្រាប់ការសាងសង់ ឬការកែសម្រួលណាមួយ
- អ្នកប្រតិបត្តិការសាងសង់ត្រូវត្រួតពិនិត្យទិន្នន័យទាំងអស់ មុននឹងចាប់ផ្តើមការងារ
- ប្រសិនបើមានការកែសម្រួលណាមួយ ត្រូវធ្វើការកែសម្រួលនេះឱ្យបានត្រឹមត្រូវ
- រាល់ការកែសម្រួលត្រូវធ្វើឡើងតាមផែនទីនេះ
- រាល់ការកែសម្រួលត្រូវធ្វើឡើងតាមការណែនាំរបស់អ្នកប្រតិបត្តិការសាងសង់
- ប្រសិនបើមានការកែសម្រួលណាមួយ ត្រូវធ្វើការកែសម្រួលនេះឱ្យបានត្រឹមត្រូវ
- ផែនទីនេះគឺជាផែនទីប្រយោជន៍ មិនមែនជាផែនទីប្រតិបត្តិការសាងសង់ឡើយ
ការអនុវត្តត្រូវធ្វើតាមផែនទីនេះ The Room Design Studio By Muraya.

WARNING
- This drawing shall not be used for construction unless certified.
- Contractor to verify all dimensions of existing works on site before commencing any work or preparing shop drawings.
- Do not scale drawings, use written dimensions only.
- All measurements in millimeters.
- All levels in meters.
- This drawing is to be read in conjunction with the specifications and conditions of contract.
- This drawing and design are copyright and no portion may be produced without the permission of The Room Design Studio By Muraya.

REVISIONS:

H		
G		
F		
E		
D		
C		
B		
A		
REF	កំណត់សម្គាល់/Remarks	Date

ឈ្មោះគម្រោង/Project Title:

UNDP

ឈ្មោះរូប/Drawing Title:

FIRST FLOOR
DEMOLITION LAYOUT

ស្ថានភាពគម្រោង/Phase:

- ☒ គម្រោងគិត/CONCEPT DESIGN
☐ គម្រោងលម្អិត/DETAILED DESIGN

ប្រតិភូ/POSITION

ឈ្មោះ/NAME

អគ្គនាយក/Director

P.J

ប្រធានក្រុមគម្រោង/Project Manager:

P.J

ត្រួតពិនិត្យ/Checked by:

P.J

ទទួលខុសត្រូវ/Drawn by:

U.D

ចេញផ្សាយ/Issued for:

ចេញផ្សាយ/Issued Date:


09 APRIL 2018

មាត្រដ្ឋាន/Scale:

1/100 (A3)

លេខគម្រោង/Drawing No:

KHATP-0221-004B

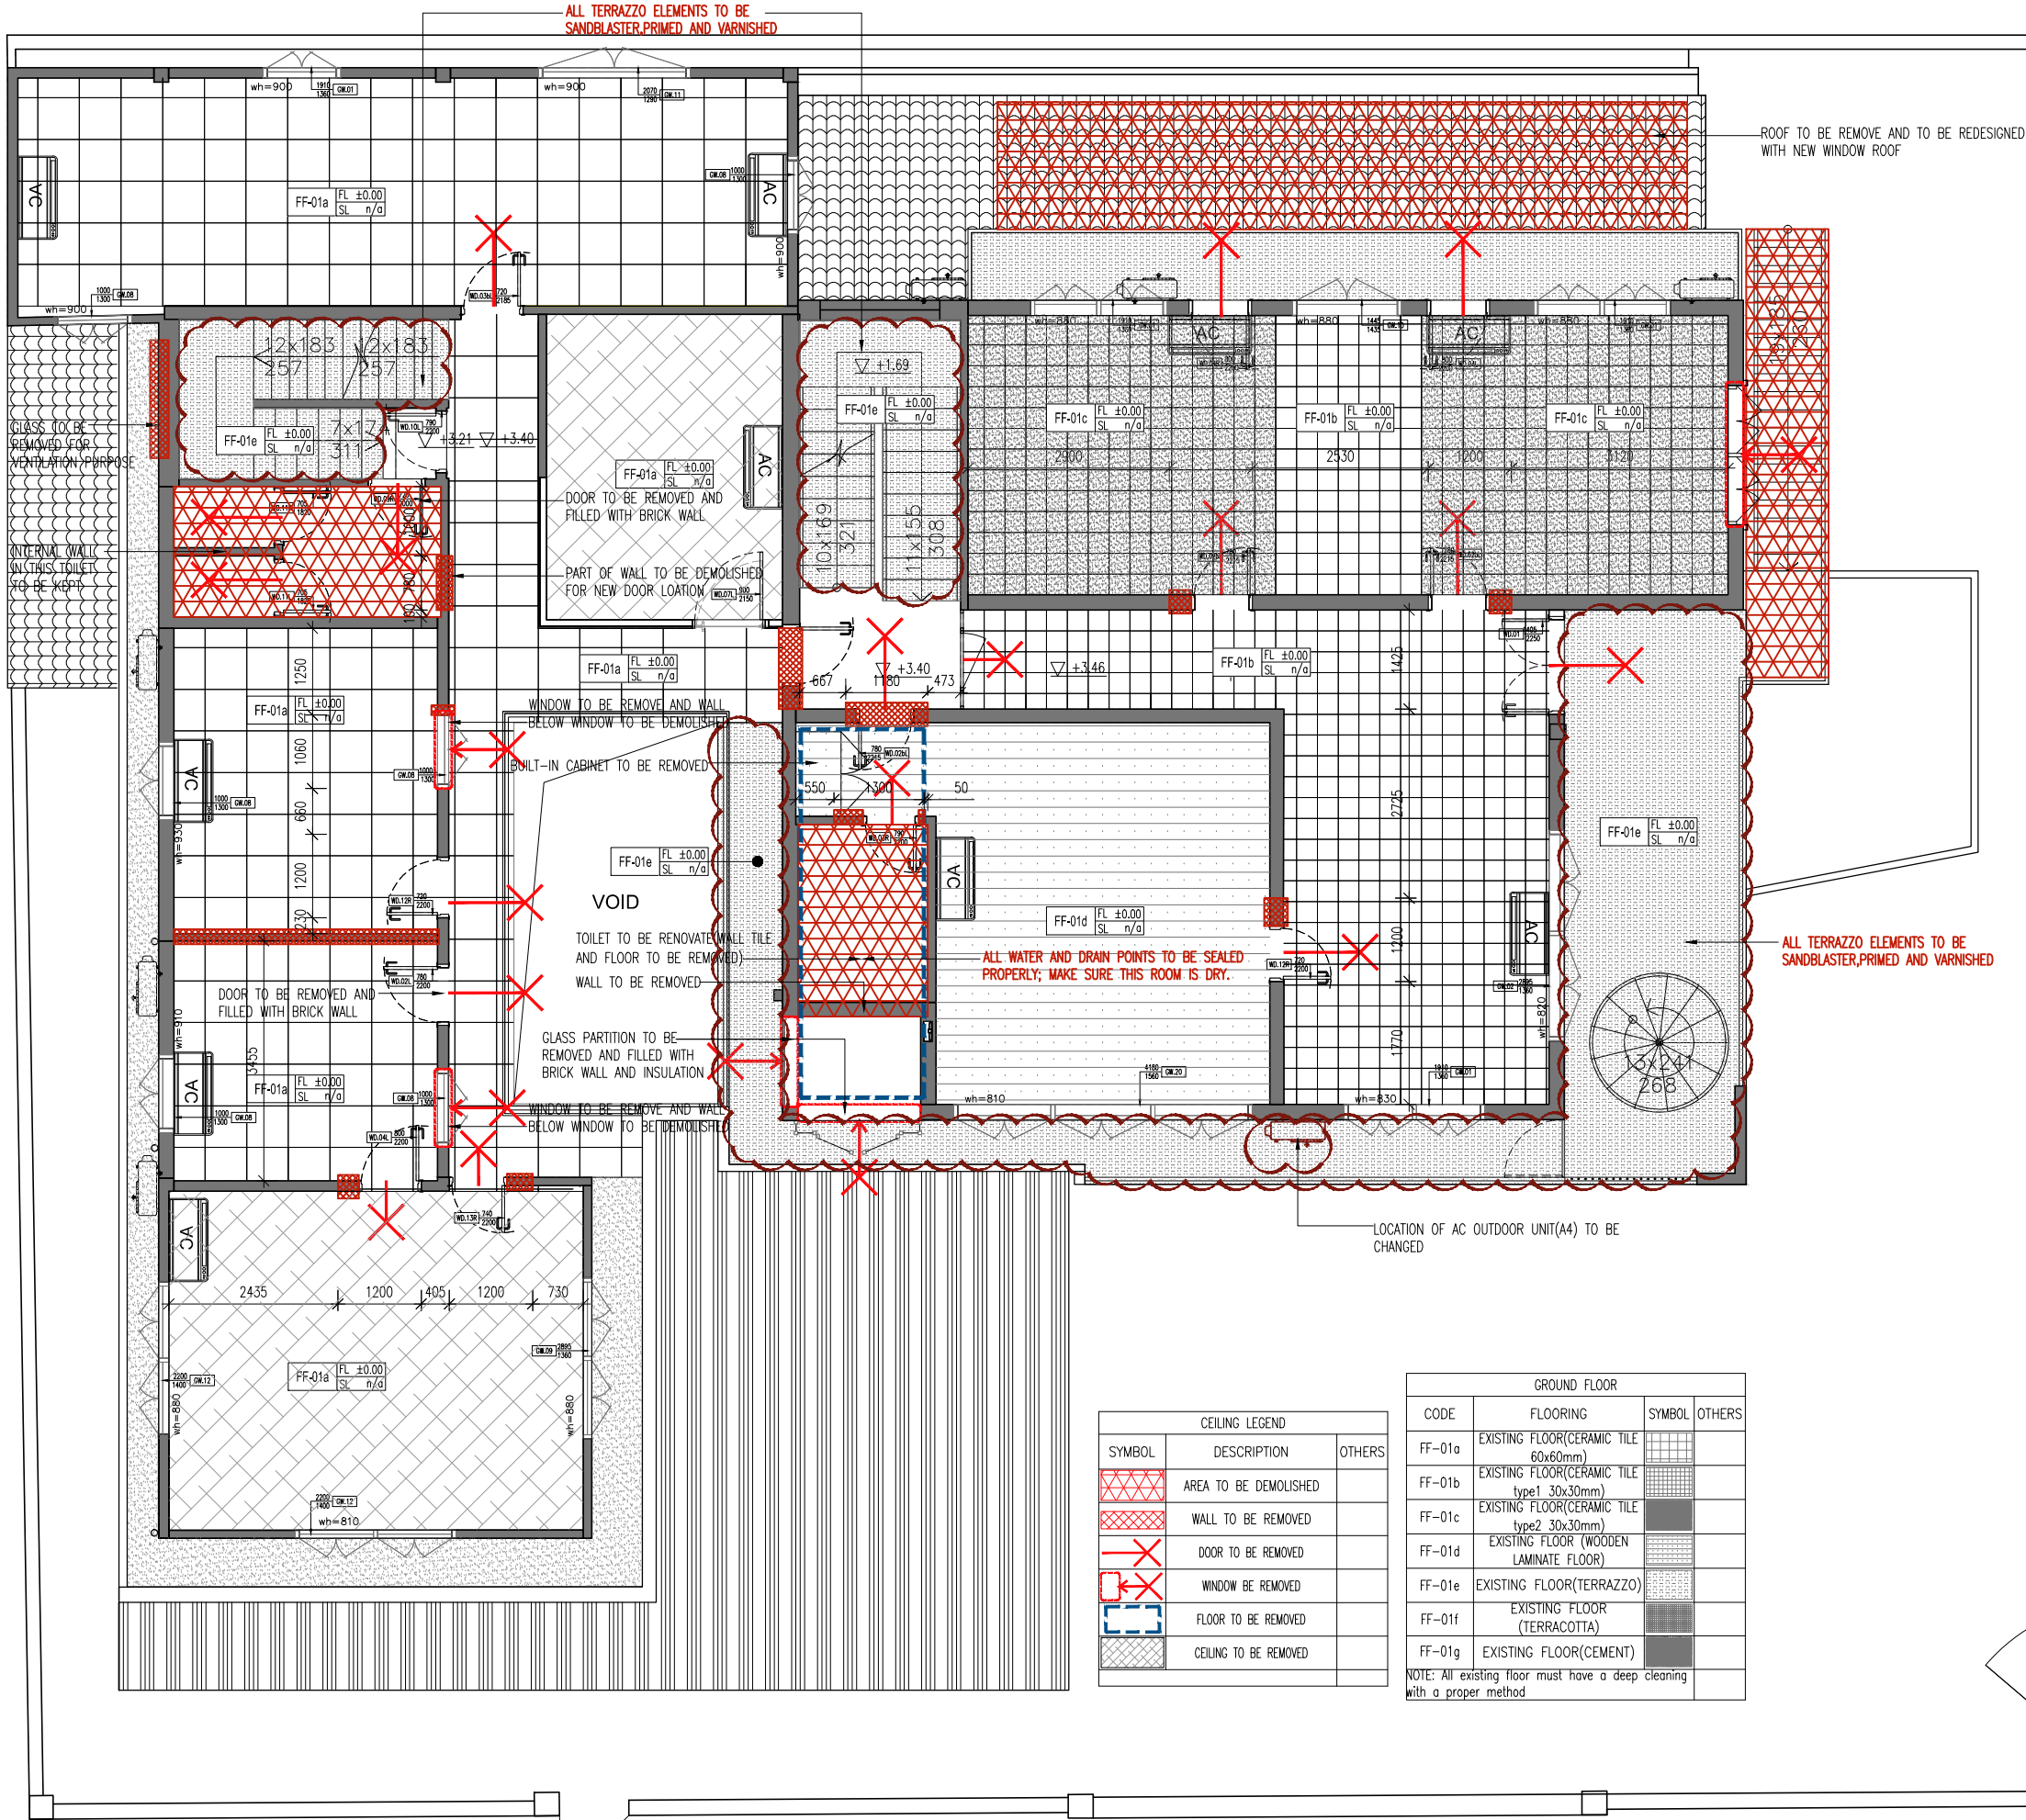

ALL TERRAZZO ELEMENTS TO BE
SANDBLASTED, PRIMED AND VARNISHED

ROOF TO BE REMOVE AND TO BE REDESIGNED
WITH NEW WINDOW ROOF

ALL TERRAZZO ELEMENTS TO BE
SANDBLASTED, PRIMED AND VARNISHED

ALL WATER AND DRAIN POINTS TO BE SEALED
PROPERLY; MAKE SURE THIS ROOM IS DRY.

LOCATION OF AC OUTDOOR UNIT(A4) TO BE
CHANGED

CEILING LEGEND		
SYMBOL	DESCRIPTION	OTHERS
	AREA TO BE DEMOLISHED	
	WALL TO BE REMOVED	
	DOOR TO BE REMOVED	
	WINDOW TO BE REMOVED	
	FLOOR TO BE REMOVED	
	CEILING TO BE REMOVED	

GROUND FLOOR			
CODE	FLOORING	SYMBOL	OTHERS
FF-01a	EXISTING FLOOR(CERAMIC TILE 60x60mm)		
FF-01b	EXISTING FLOOR(CERAMIC TILE type1 30x30mm)		
FF-01c	EXISTING FLOOR(CERAMIC TILE type2 30x30mm)		
FF-01d	EXISTING FLOOR (WOODEN LAMINATE FLOOR)		
FF-01e	EXISTING FLOOR(TERRAZZO)		
FF-01f	EXISTING FLOOR (TERRACOTTA)		
FF-01g	EXISTING FLOOR(CEMENT)		

NOTE: All existing floor must have a deep cleaning
with a proper method

NOTE:

-ALL STEEL ELEMENTS(RAILING, EXTERNAL STAIR, GATE, AND WINDOW STEEL BAR TO BE SANDBLASTED)
-ALL EXTERNAL FLOORING TO BE DEEP CLEANED.

-ALL INTERNAL FLOOR TILES TO HAVE A PRESSURE WASHING OR OTHER RELEVANT EFFECTIVE
CLEANING METHOD FOR A DEEP CLEANING.
-ALL WALL AND FENCE TO BE CLEANED OUT DAMAGED PAINTED, AND TO BE REPAINTED.

-IN ROOF SEAL TO BE CHECKED.

-ALL WINDOW AND WINDOW STEEL BAR TO BE REMOVED AND REPLACE BY NEW WINDOWS&STEEL BAR.




Tel: 023 993 620
www.theroomds.com

កំណត់សំគាល់:

- WARNING**
- This drawing shall not be used for construction unless certified.
 - Contractor to verify all dimensions of existing works on site before commencing any work or preparing shop drawings.
 - Do not scale drawings, use written dimensions only.
 - All measurements in millimeters.
 - All levels in meters.
 - This drawing is to be read in conjunction with the specifications and conditions of contract.
 - This drawing and design are copyright and no portion may be produced without the permission of **The Room Design Studio By Kurya.**

H		
G		
F		
E		
D		
C		
B		
A	-----	-----
REF.	ลักษณะพิเศษ / Remarks	Date

ចេញផ្សាយ/Issued Date: 09 APRIL 2018	មាត្រដ្ឋាន/Scale: 1/100 (A3)
លេខផែនទី/Drawing No: KHATP-0221-005A	

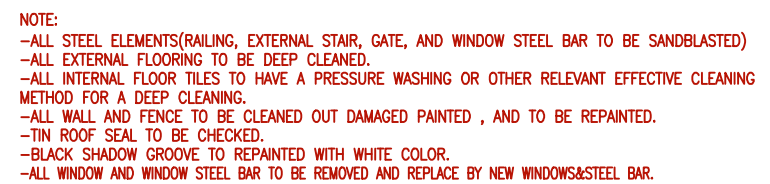



Tel: 023 993 620
www.theroomds.com

ឈរ/ Drawing No:
KHATP-0221-005B



NOTE:

- ALL STEEL ELEMENTS(RAILING, EXTERNAL STAIR, GATE, AND WINDOW STEEL BAR TO BE SANDBLASTED)
- ALL EXTERNAL FLOORING TO BE DEEP CLEANED.
- ALL INTERNAL FLOOR TILES TO HAVE A PRESSURE WASHING OR OTHER RELEVANT EFFECTIVE CLEANING METHOD FOR A DEEP CLEANING.
- ALL WALL AND FENCE TO BE CLEANED OUT DAMAGED PAINTED , AND TO BE REPAINTED.
- TIN ROOF SEAL TO BE CHECKED.
- BLACK SHADOW GROOVE TO REPAINTED WITH WHITE COLOR.
- ALL WINDOW AND WINDOW STEEL BAR TO BE REMOVED AND REPLACE BY NEW WINDOWS&STEEL BAR.

THE ROOM
DESIGN STUDIO BY MURAYA

Tel: 023 993 620
www.theroomds.com

WARNING

- This drawing shall not be used for construction unless certified.
- Contractor to verify all dimensions of existing works on site before commencing any work or preparing shop drawings.
- Do not scale drawings, use written dimensions only.
- **All measurements in millimeters.**
- All levels in meters.
- This drawing is to be read in conjunction with the specifications and conditions of contract.
- This drawing and design are copyright and no portion may be produced without the permission of **The Room Design Studio By Muraya.**

H		
G		
F		
E		
D		
C		
B		
A	-----	-----
REF.	พิจารณา/Remarks	D

លេខសម្គាល់/Drawing No:
KHATP-0221-005C



NOTE:

- ALL STEEL ELEMENTS(RAILING, EXTERNAL STAIR, GATE, AND WINDOW STEEL BAR TO BE SANDBLASTED)
- ALL INTERNAL FLOORING TO BE DEEP CLEANED.
- ALL INTERNAL FLOOR TILES TO HAVE A PRESSURE WASHING OR OTHER RELEVANT EFFECTIVE CLEANING METHOD FOR A DEEP CLEANING.
- ALL WALL AND FENCE TO BE CLEANED OUT DAMAGED PAINTED , AND TO BE REPAINTED.
- TIN ROOF SEAL TO BE CHECKED.
- BLACK SHADOW GROOVE TO REPAINTED WITH WHITE COLOR.
- ALL WINDOW AND WINDOW STEEL BAR TO BE REMOVED AND REPLACE BY NEW WINDOWS&STEEL BAR.



4 NORTH ELEVATION (SIDE VIEW)
1/100

NOTE:
-ALL STEEL ELEMENTS(RAILING, EXTERNAL STAIR, GATE, AND WINDOW STEEL BAR TO BE SANDBLASTED)
-ALL EXTERNAL FLOORING TO BE DEEP CLEANED.
-ALL INTERNAL FLOOR TILES TO HAVE A PRESSURE WASHING OR OTHER RELEVANT EFFECTIVE CLEANING METHOD FOR A DEEP CLEANING.
-ALL WALL AND FENCE TO BE CLEANED OUT DAMAGED PAINTED , AND TO BE REPAINTED.
-TIN ROOF SEAL TO BE CHECKED.
-BLACK SHADOW GROOVE TO REPAINTED WITH WHITE COLOR.
-ALL WINDOW AND WINDOW STEEL BAR TO BE REMOVED AND REPLACE BY NEW WINDOWS&STEEL BAR.

PROJECT OWNER
UNDP

THE ROOM

DESIGN STUDIO BY MURAYA

Architecture | Interior Design

Tel: 023 993 620
www.theroomds.com

KEY PLAN / NOTE

កំណត់សំគាល់:

- មិនត្រូវប្រើប្រាស់ប្លង់នេះសម្រាប់ការសាងសង់ឡើយ ពួកគេត្រូវតែប្រើប្រាស់ប្លង់សម្រាប់ការសាងសង់
- អ្នកសាងសង់ត្រូវត្រួតពិនិត្យប្លង់នៅកន្លែងសាងសង់ មុនពេលចាប់ផ្តើមការសាងសង់
- ប្លង់នេះត្រូវបានរៀបចំឡើងដោយប្រើប្រាស់ប្លង់ប្រតិបត្តិការដែលបានផ្តល់ជូនដោយអ្នកប្រកាស
- ប្លង់នេះត្រូវបានរៀបចំឡើងដោយប្រើប្រាស់ប្លង់ប្រតិបត្តិការដែលបានផ្តល់ជូនដោយអ្នកប្រកាស
- ប្លង់នេះត្រូវបានរៀបចំឡើងដោយប្រើប្រាស់ប្លង់ប្រតិបត្តិការដែលបានផ្តល់ជូនដោយអ្នកប្រកាស
- ប្លង់នេះត្រូវបានរៀបចំឡើងដោយប្រើប្រាស់ប្លង់ប្រតិបត្តិការដែលបានផ្តល់ជូនដោយអ្នកប្រកាស
- ប្លង់នេះត្រូវបានរៀបចំឡើងដោយប្រើប្រាស់ប្លង់ប្រតិបត្តិការដែលបានផ្តល់ជូនដោយអ្នកប្រកាស
- ប្លង់នេះត្រូវបានរៀបចំឡើងដោយប្រើប្រាស់ប្លង់ប្រតិបត្តិការដែលបានផ្តល់ជូនដោយអ្នកប្រកាស
- ប្លង់នេះត្រូវបានរៀបចំឡើងដោយប្រើប្រាស់ប្លង់ប្រតិបត្តិការដែលបានផ្តល់ជូនដោយអ្នកប្រកាស
- ប្លង់នេះត្រូវបានរៀបចំឡើងដោយប្រើប្រាស់ប្លង់ប្រតិបត្តិការដែលបានផ្តល់ជូនដោយអ្នកប្រកាស

WARNING

- This drawing shall not be used for construction unless certified.
- Contractor to verify all dimensions of existing works on site before commencing any work or preparing shop drawings.
- Do not scale drawings, use written dimensions only.
- All measurements in millimeters.
- All levels in meters.
- This drawing is to be read in conjunction with the specifications and conditions of contract.
- This drawing and design are copyright and no portion may be produced without the permission of The Room Design Studio By Muraya.

REVISIONS:

H		
G		
F		
E		
D		
C		
B		
A		

REF: កំណត់សំគាល់/RemarksDate

ឈ្មោះគម្រោង/Project Title:
UNDP

ឈ្មោះប្រភេទ/Drawing Title:
DEMOLITION ELEVATION
NORTH ELEVATION (SIDE VIEW)

ចំណាត់ការគម្រោង/Phase:
☒ ប្រភេទគំនិត/CONCEPT DESIGN
☐ ប្រភេទគំនិត/DETAILED DESIGN


ប្រភេទគំនិត/POSITION	ឈ្មោះ/NAME
អគ្គនាយក/Director:	P.J
ប្រធានក្រុមគម្រោង/Project Manager:	P.J
ពិនិត្យ/Checked by:	P.J
គូរ/Drawn by:	D.L

ឈ្មោះ/Issued for:

ចេញផ្សាយ/Issued Date:
09 APRIL 2018

មាត្រដ្ឋាន/Scale:
1/100 (A3)

លេខគម្រោង/Drawing No:
KHATP-0221-005D

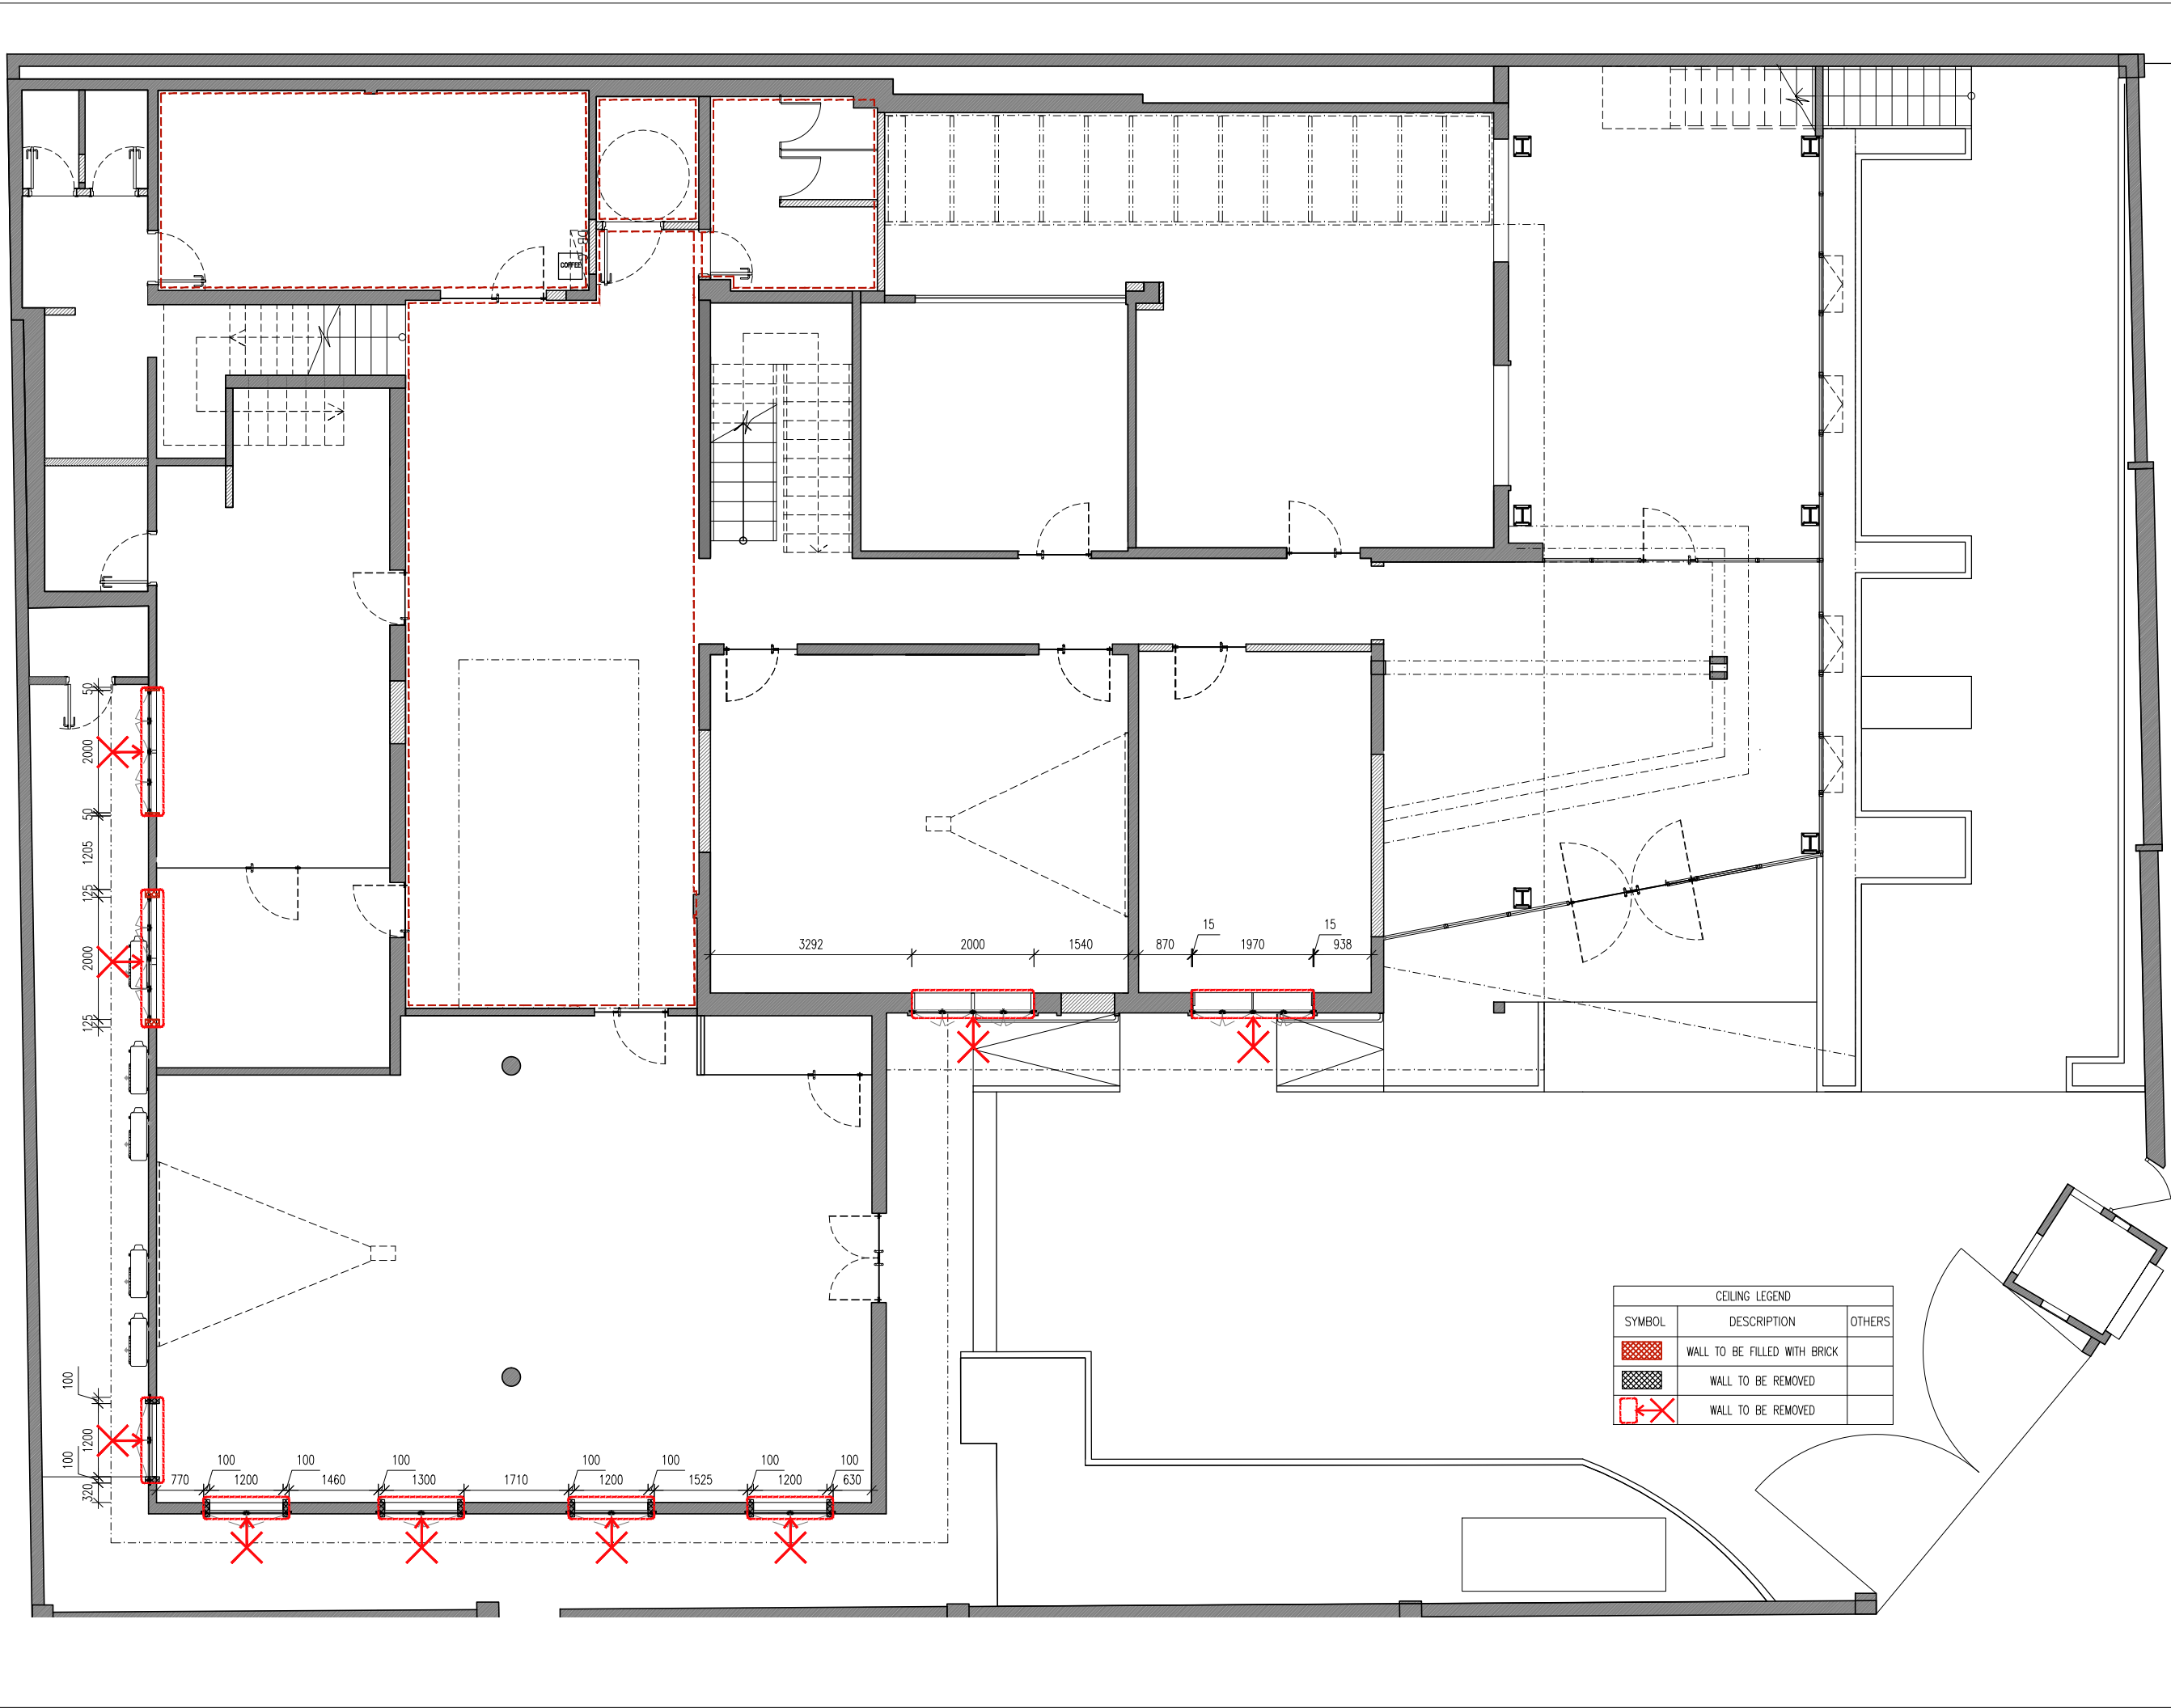

CEILING LEGEND		
SYMBOL	DESCRIPTION	OTHERS
	WALL TO BE FILLED WITH BRICK	
	WALL TO BE REMOVED	
	WALL TO BE REMOVED	

PROJECT OWNER
UNDP

THE ROOM

DESIGN STUDIO BY MURAYA

Architecture | Interior Design

Tel: 023 993 620
www.therooms.com

KEY PLAN / NOTE

កំណត់សម្គាល់:

- មិនត្រូវប្រើប្រាស់ផែនទីនេះសម្រាប់ការសាងសង់ឡើយ ពួកគេត្រូវតែប្រើប្រាស់ផែនទីដើមប៉ុណ្ណោះ
- អ្នកកាត់សម្រាប់ត្រូវតែប្រើប្រាស់ផែនទីនេះ មុនពេលចាប់ផ្តើមការងារ
- ប្រសិនបើមានការកែសម្រួល ឬប្រែប្រួលទៅលើផែនទីនេះ ត្រូវតែមានការអនុញ្ញាតពីអ្នករៀបចំផែនទី
- រាល់ការកែសម្រួលត្រូវតែធ្វើឡើងតាមការណែនាំរបស់អ្នករៀបចំផែនទី
- ប្រសិនបើមានការកែសម្រួលទៅលើផែនទីនេះ ត្រូវតែមានការអនុញ្ញាតពីអ្នករៀបចំផែនទី
- ផែនទីនេះត្រូវតែប្រើប្រាស់តាមការណែនាំរបស់អ្នករៀបចំផែនទី
- ផែនទីនេះគឺជាផលិតផលរបស់ The Room Design Studio By Muraya.

WARNING

- This drawing shall not be used for construction unless certified.
- Contractor to verify all dimensions of existing works on site before commencing any work or preparing shop drawings.
- Do not scale drawings, use written dimensions only.
- All measurements in millimeters.
- All levels in meters.
- This drawing is to be read in conjunction with the specifications and conditions of contract.
- This drawing and design are copyright and no portion may be produced without the permission of The Room Design Studio By Muraya.

REVISIONS:

H		
G		
F		
E		
D		
C		
B		
A		

REF	កំណត់សម្គាល់/Remarks	Date

ឈ្មោះគម្រោង/Project Title:
UNDP


ឈ្មោះផែនទី/Drawing Title:
GROUND FLOOR
DEMOLITION WINDOW LAYOUT

ស្ថានភាពគម្រោង/Phase:
☒ គម្រោងគិត/CONCEPT DESIGN
☐ គម្រោងលម្អិត/DETAILED DESIGN

ប្រតិភូ/POSITION	ឈ្មោះ/NAME
អគ្គនាយក/Director:	P.J
ប្រធានក្រុមគម្រោង/Project Manager:	P.J
ត្រួតពិនិត្យ/Checked by:	P.J
គូរផែនទី/Drawn by:	D.L

ចេញផ្សាយ/Issued for:

ចេញផ្សាយ/Issued Date: 09 APRIL 2018	មាត្រដ្ឋាន/Scale: 1/100 (A3)
លេខផែនទី/Drawing No: KHATP-0221-006A	

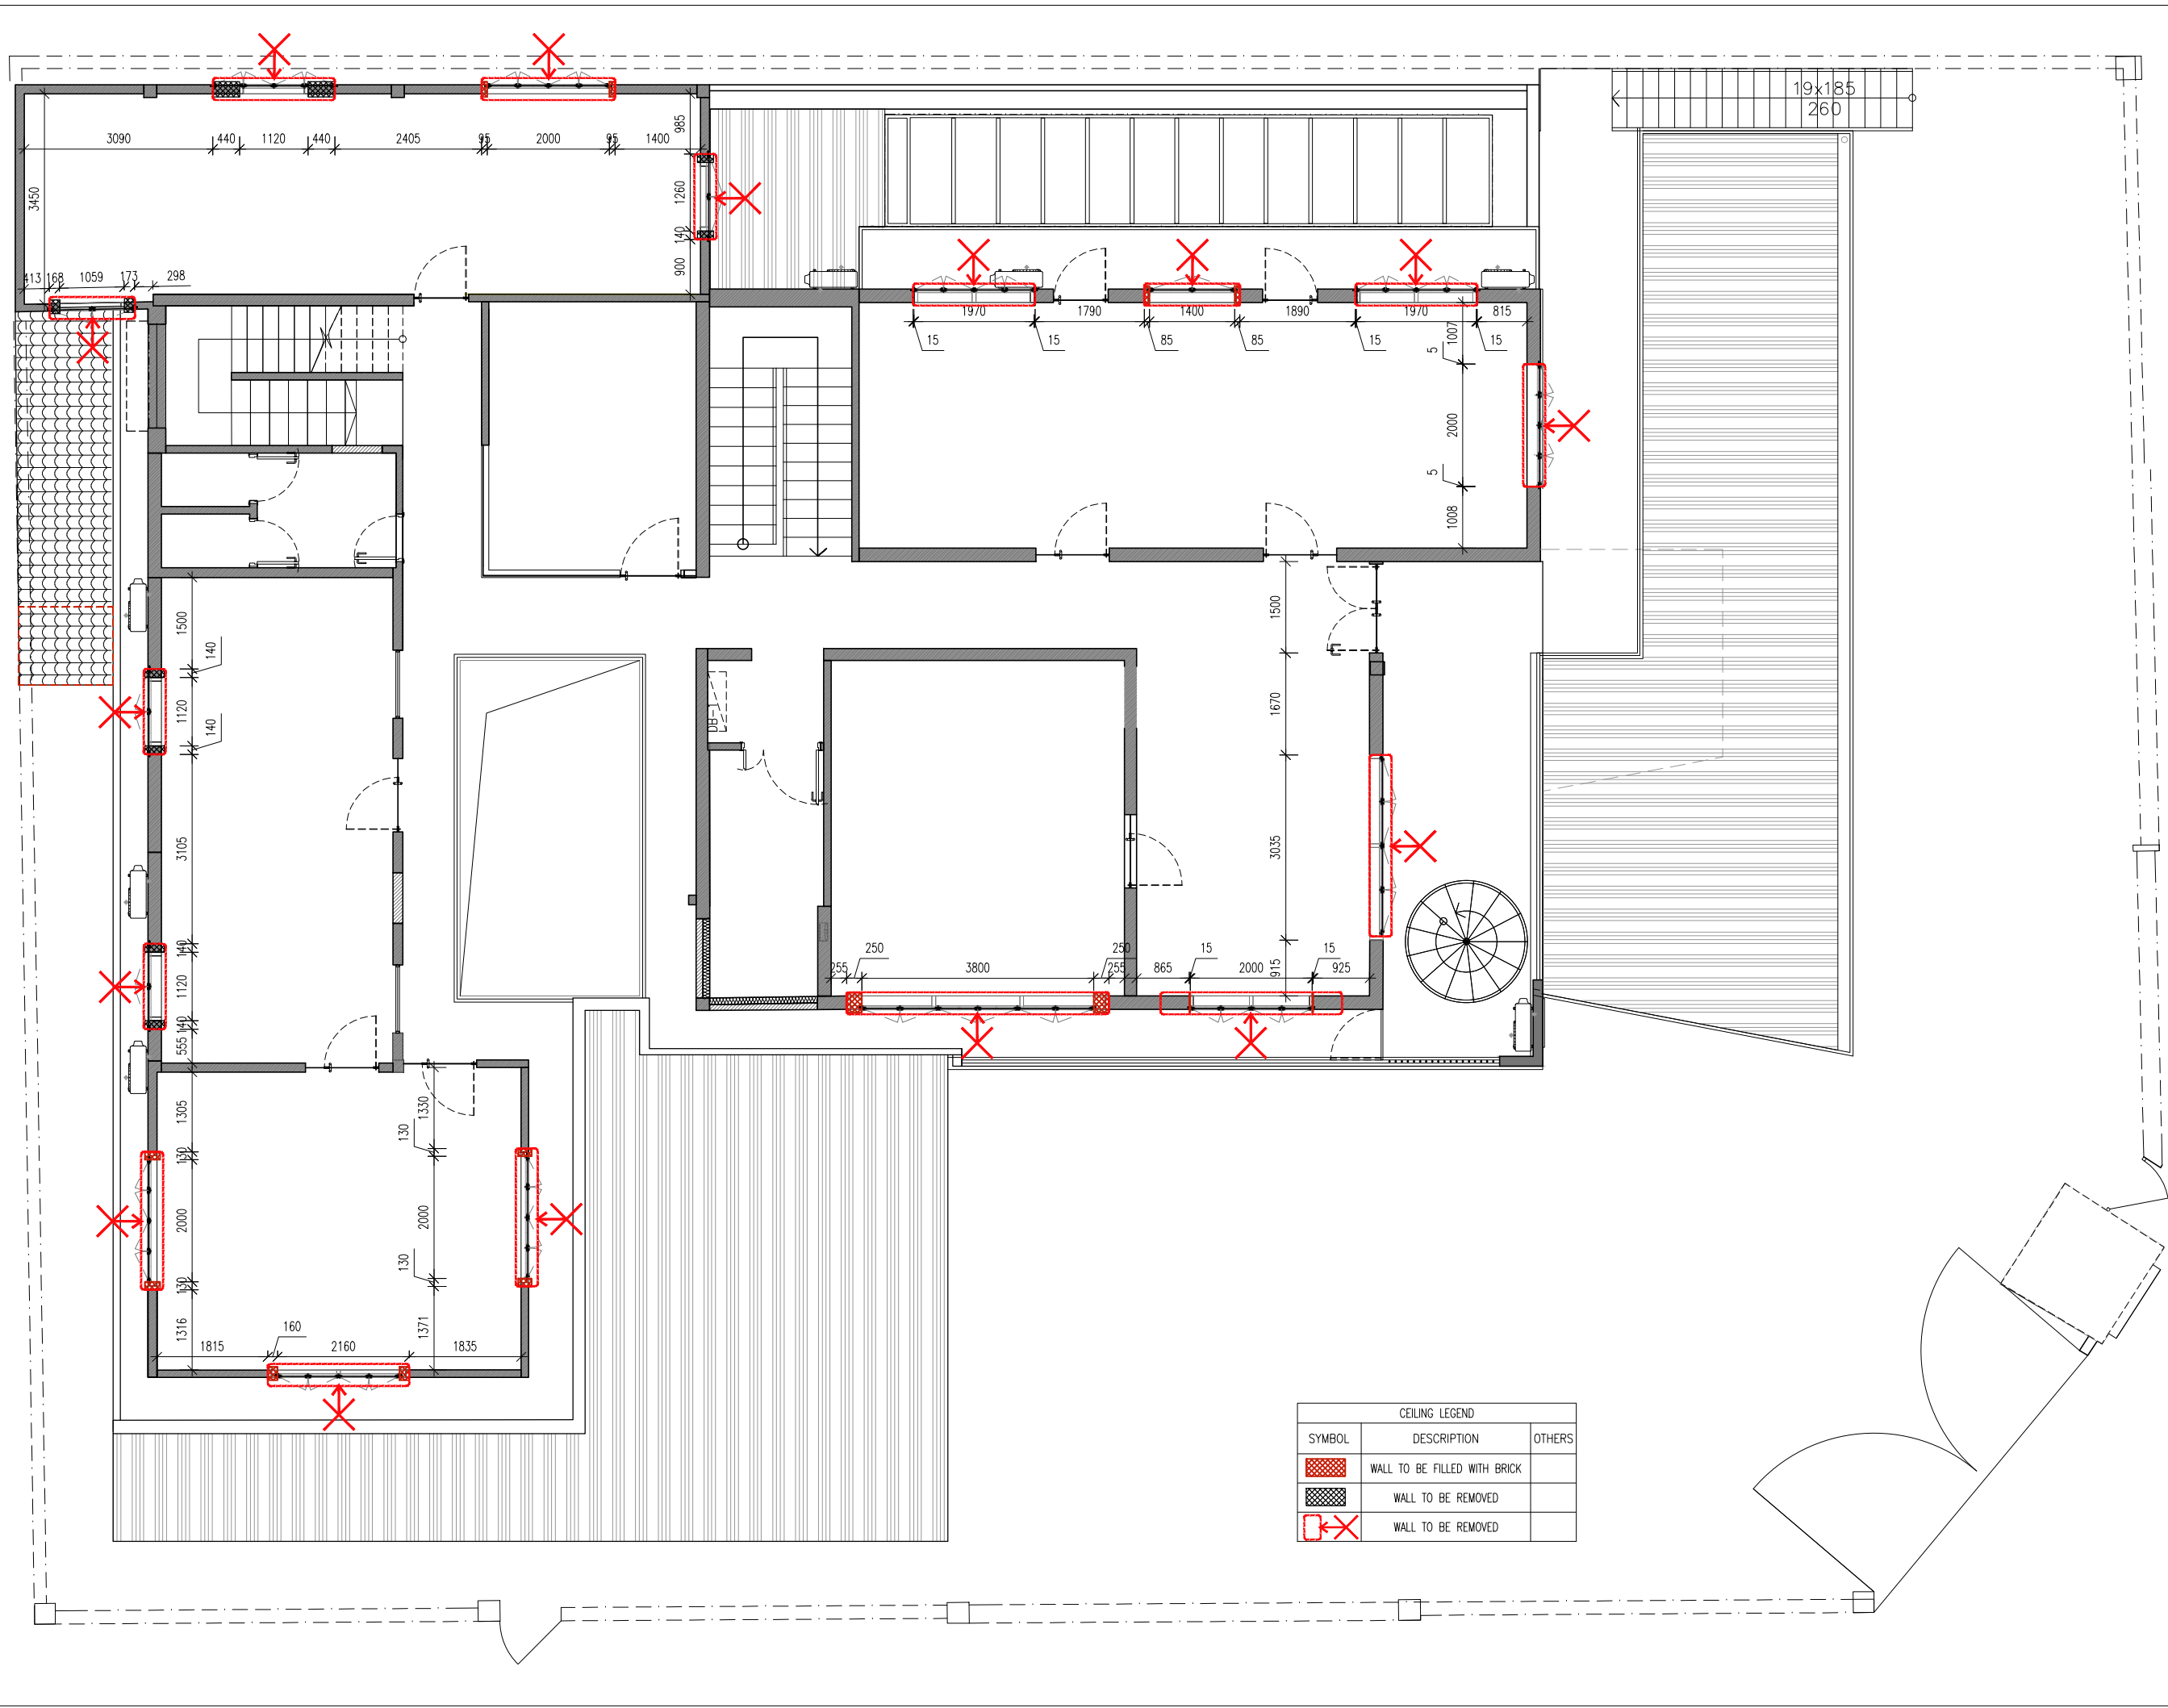

CEILING LEGEND		
SYMBOL	DESCRIPTION	OTHERS
	WALL TO BE FILLED WITH BRICK	
	WALL TO BE REMOVED	
	WALL TO BE REMOVED	

PROJECT OWNER
UNDP

THE ROOM

DESIGN STUDIO BY MURAYA

Architecture | Interior Design

Tel: 023 993 620
www.therooms.com

KEY PLAN / NOTE

កំណត់សម្គាល់:

- មិនត្រូវប្រើប្រាស់ផែនទីនេះសម្រាប់ការសាងសង់ឡើយ ពួកគេត្រូវតែទាញយកមកប្រើប្រាស់
- អ្នកសាងសង់ត្រូវត្រួតពិនិត្យទៅលើការសាងសង់ មុនពេលបើកការសាងសង់
- មិនអាចសាងសង់បានដូចដែលបានបង្ហាញ ប្រសិនបើមានការផ្លាស់ប្តូរណាមួយ
- រាល់ការផ្លាស់ប្តូរត្រូវបានអនុម័តដោយអ្នករៀបចំ
- រាល់ការផ្លាស់ប្តូរត្រូវបានអនុម័តដោយអ្នករៀបចំ
- ប្រសិនបើមានការផ្លាស់ប្តូរណាមួយ អ្នកសាងសង់ត្រូវត្រួតពិនិត្យទៅលើការសាងសង់
- ផែនទីនេះគឺជាផែនទីប្រើប្រាស់ មិនអាចប្រើប្រាស់ ឬចម្លងបានដោយអ្នកសាងសង់

The Room Design Studio By Muraya.

WARNING

- This drawing shall not be used for construction unless certified.
- Contractor to verify all dimensions of existing works on site before commencing any work or preparing shop drawings.
- Do not scale drawings, use written dimensions only.
- All measurements in millimeters.
- All levels in meters.
- This drawing is to be read in conjunction with the specifications and conditions of contract.
- This drawing and design are copyright and no portion may be produced without the permission of The Room Design Studio By Muraya.

REVISIONS:

H		
G		
F		
E		
D		
C		
B		
A		

REF: កំណត់សម្គាល់/Remarks

Date

ឈ្មោះគម្រោង/Project Title:

UNDP

ឈ្មោះរូប/Drawing Title:

FIRST FLOOR
DEMOLITION WINDOW LAYOUT

ចំណាត់ការគម្រោង/Phase:

ប្រភេទគំនិត/CONCEPT DESIGN

ប្រភេទគំនិត/DETAILED DESIGN


អ្នករៀបចំ/POSITION	ឈ្មោះ/NAME
អគ្គនាយក/Director:	P.J
ប្រធានក្រុមគម្រោង/Project Manager:	P.J
ពិនិត្យ/Checked by:	P.J
ទាញ/Drawn by:	D.L

ឈ្មោះ/Issued for:

ឈ្មោះ/Issued Date:
09 APRIL 2018

មាត្រដ្ឋាន/Scale:
1/100 (A3)

លេខគម្រោង/Drawing No:
KHATP-0221-006B

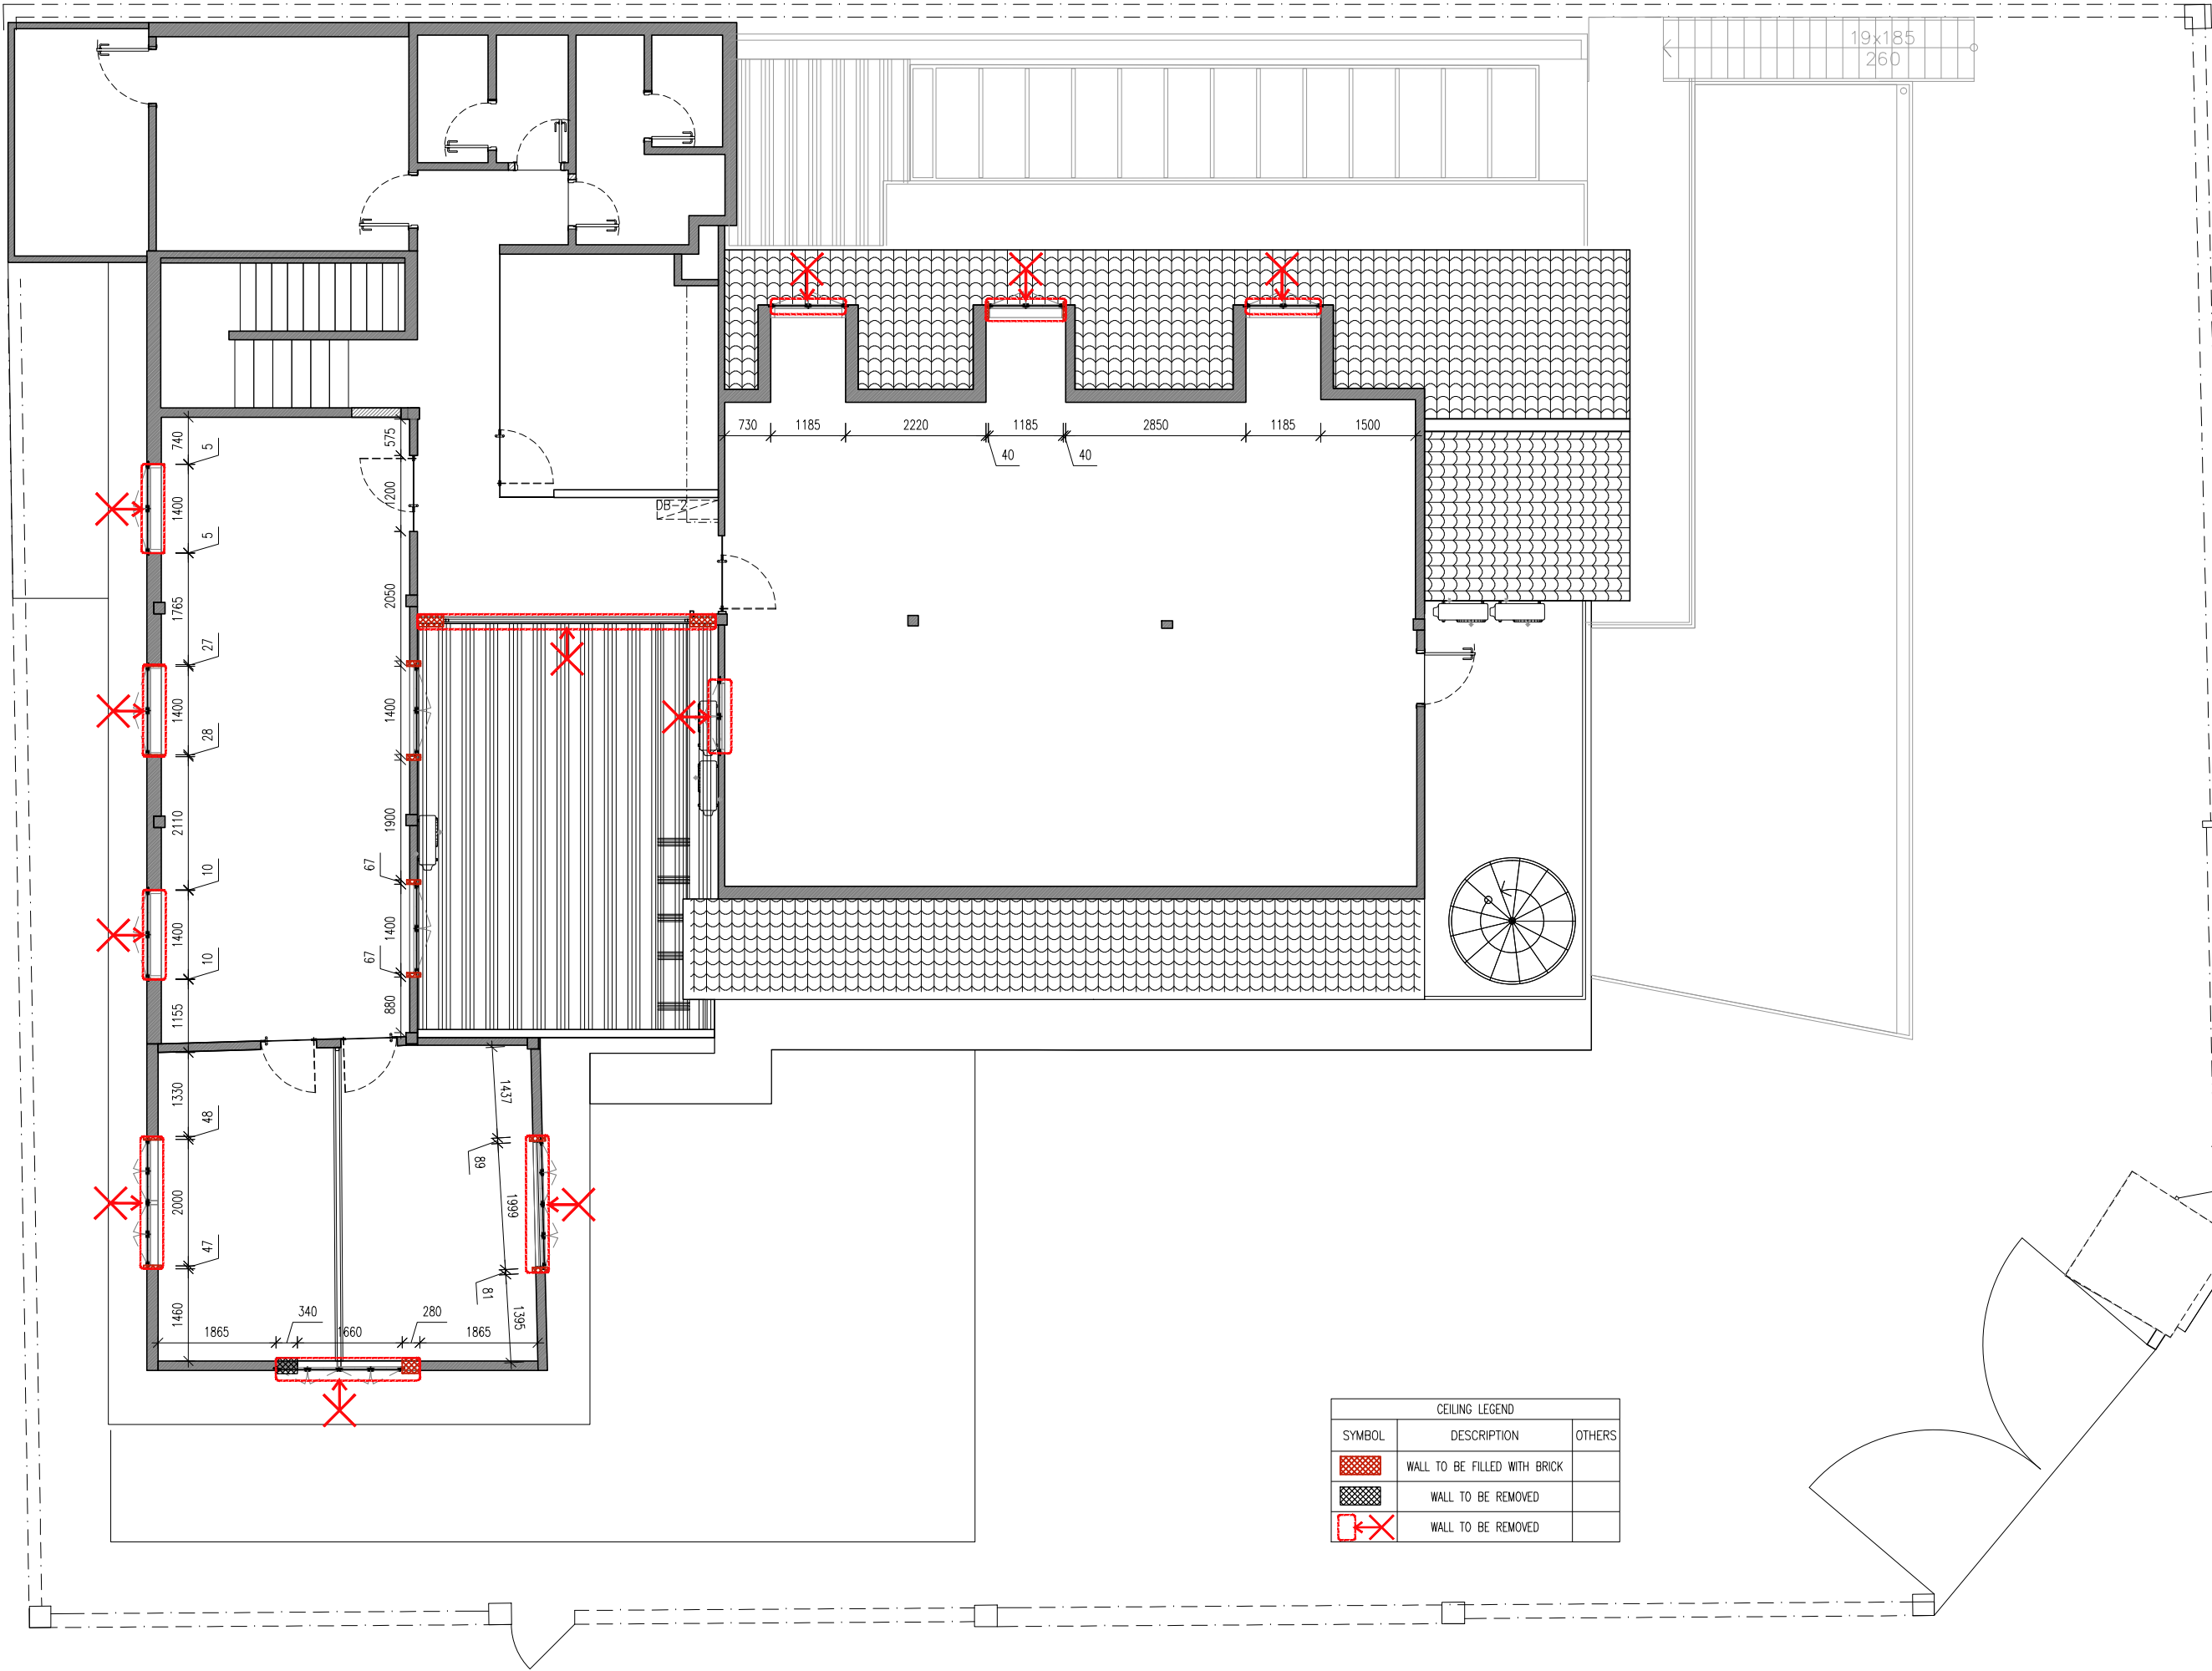

CEILING LEGEND		
SYMBOL	DESCRIPTION	OTHERS
	WALL TO BE FILLED WITH BRICK	
	WALL TO BE REMOVED	
	WALL TO BE REMOVED	

PROJECT OWNER
UNDP

THE ROOM

DESIGN STUDIO BY MURAYA

Architecture | Interior Design

Tel: 023 993 620
www.therooms.com

KEY PLAN / NOTE

កំណត់សម្គាល់:

- មិនត្រូវប្រើប្រាស់ផែនទីនេះសម្រាប់ការសាងសង់ឡើយ ពួកគេត្រូវតែប្រើប្រាស់ផែនទីដើមប៉ុណ្ណោះ
- អ្នកសាងសង់ត្រូវត្រួតពិនិត្យទៅលើការដាក់ទីតាំង មុនពេលបើកការសាងសង់
- មិនអាចកាត់ទ្វារបានដើម្បីបំប្លែង ប្រើប្រាស់ផែនទីនេះសម្រាប់ការសាងសង់ឡើយ
- មិនមែនជាផែនទីសម្រាប់ប្រើប្រាស់
- រាល់ការកាត់ទ្វារត្រូវតែដាក់ប្រើប្រាស់
- រាល់ការកាត់ទ្វារត្រូវតែដាក់ប្រើប្រាស់
- ប្រសិនបើមានការកាត់ទ្វារត្រូវតែដាក់ប្រើប្រាស់
- មិនអាចកាត់ទ្វារបានដើម្បីបំប្លែង ប្រើប្រាស់ផែនទីនេះសម្រាប់ការសាងសង់ឡើយ

WARNING

- This drawing shall not be used for construction unless certified.
- Contractor to verify all dimensions of existing works on site before commencing any work or preparing shop drawings.
- Do not scale drawings, use written dimensions only.
- All measurements in millimeters.
- All levels in meters.
- This drawing is to be read in conjunction with the specifications and conditions of contract.
- This drawing and design are copyright and no portion may be produced without the permission of The Room Design Studio By Muraya.

REVISIONS:

H		
G		
F		
E		
D		
C		
B		
A		

REF: កំណត់សម្គាល់/RemarksDate

ឈ្មោះគម្រោង/Project Title:

UNDP

ឈ្មោះរូប/Drawing Title:

SECOND FLOOR
DEMOLITION WINDOW LAYOUT

ចំណាត់ការ/Phase:

ប្រភេទគំនិត/CONCEPT DESIGN

ប្រភេទគំនិត/DETAILED DESIGN

ប្រភេទគំនិត/POSITION

ឈ្មោះ/NAME

អគ្គនាយក/Director:

P.J

ប្រធានគម្រោង/Project Manager:

P.J

ត្រួតពិនិត្យ/Checked by:

P.J

គូររូប/Drawn by:

DL

ចេញផ្សាយ/Issued for:

ចេញផ្សាយ/Issued Date:


09 APRIL 2018

មាត្រដ្ឋាន/Scale:

1/100 (A3)

លេខគម្រោង/Drawing No:

KHATP-0221-006C

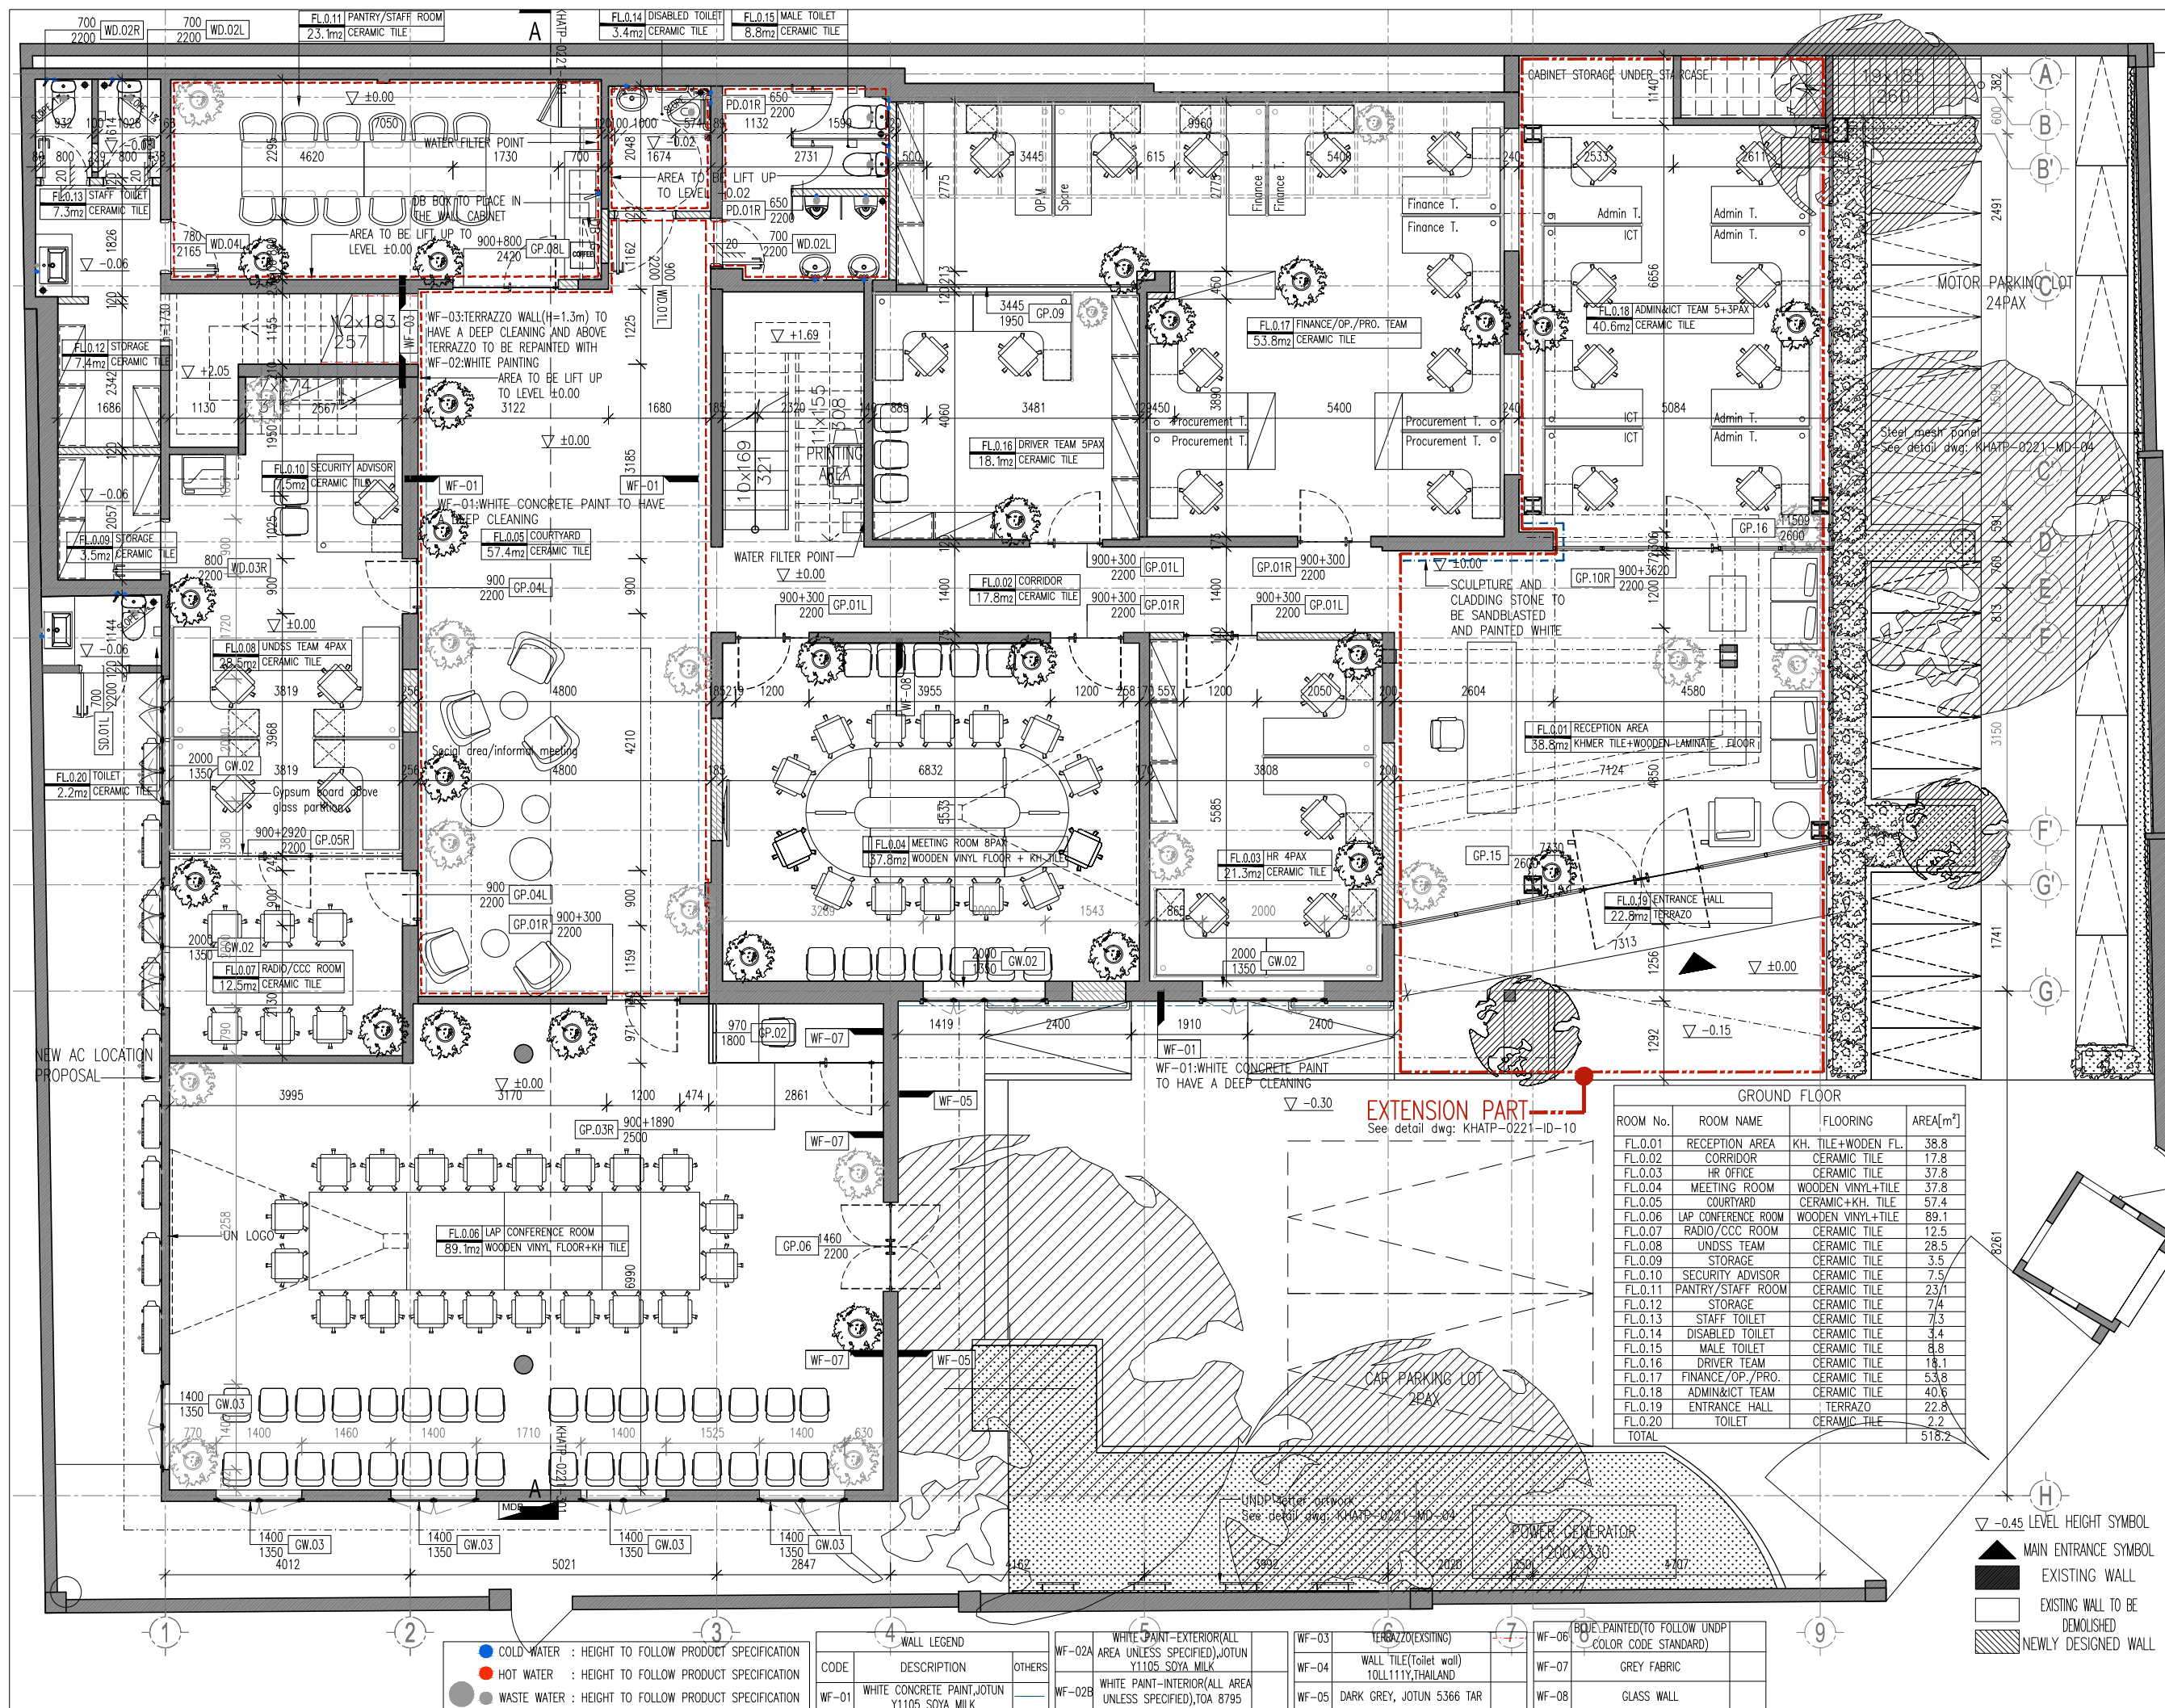

PROJECT OWNER

UNDP

THE ROOM

DESIGN STUDIO BY MURAYA

Architecture | Interior Design

Tel: 023 993 620
www.therooms.com

KEY PLAN / NOTE

ការព្រាងផែនការ:

- មិនត្រូវប្រើប្រាស់ផែនការនេះសម្រាប់ការសាងសង់ឡើយ ព្រោះវាមិនមែនជាផែនការសាងសង់ឡើយ

- ម្ចាស់គម្រោងត្រូវតែប្រើប្រាស់ផែនការនេះជាមួយផែនការសាងសង់ផ្សេងៗទៀត ដើម្បីទទួលបានផែនការសាងសង់ពេញលេញ

- ម្ចាស់គម្រោងត្រូវតែប្រើប្រាស់ផែនការនេះជាមួយផែនការសាងសង់ផ្សេងៗទៀត ដើម្បីទទួលបានផែនការសាងសង់ពេញលេញ

- ម្ចាស់គម្រោងត្រូវតែប្រើប្រាស់ផែនការនេះជាមួយផែនការសាងសង់ផ្សេងៗទៀត ដើម្បីទទួលបានផែនការសាងសង់ពេញលេញ

- ម្ចាស់គម្រោងត្រូវតែប្រើប្រាស់ផែនការនេះជាមួយផែនការសាងសង់ផ្សេងៗទៀត ដើម្បីទទួលបានផែនការសាងសង់ពេញលេញ

- ម្ចាស់គម្រោងត្រូវតែប្រើប្រាស់ផែនការនេះជាមួយផែនការសាងសង់ផ្សេងៗទៀត ដើម្បីទទួលបានផែនការសាងសង់ពេញលេញ

WARNING

- This drawing shall not be used for construction unless certified.

- Contractor to verify all dimensions of existing works on site before commencing any work or preparing shop drawings.

- Do not scale drawings, use written dimensions only.

- All measurements in millimeters.

- All levels in meters.

- This drawing is to be read in conjunction with the specifications and conditions of contract.

- This drawing and design are copyright and no portion may be produced without the permission of The Room Design Studio By Muraya.

REVISIONS:

H

G

F

E

D

C

B

A

Revision 1

2018.04.24

REF: អំណាចការណ៍/Remarks

Date

ឈ្មោះគម្រោង/Project Title:

UNDP

ឈ្មោះរូប/Drawing Title:

GROUND FLOOR LAYOUT

ស្ថាប័ន/Phase:

● ប្រតិបត្តិការ/CONCEPT DESIGN

● ប្រតិបត្តិការ/DETAILED DESIGN

បុគ្គលិក/POSITION

ឈ្មោះ/NAME

អគ្គនាយក/Director:

P.J

ប្រធានការងារគម្រោង/Project Manager:

P.J

ត្រួតពិនិត្យ/Checked by:

P.J

គូររូប/Drawn by:

U.D

ចេញផ្សាយ/Issued for:

ចេញផ្សាយ/Issued Date:


09 APRIL 2018

មា្រត្រូវ/Scale:

1/100 (A3)

ឈ្មោះរូប/Drawing No:

KHATP-0221_101A

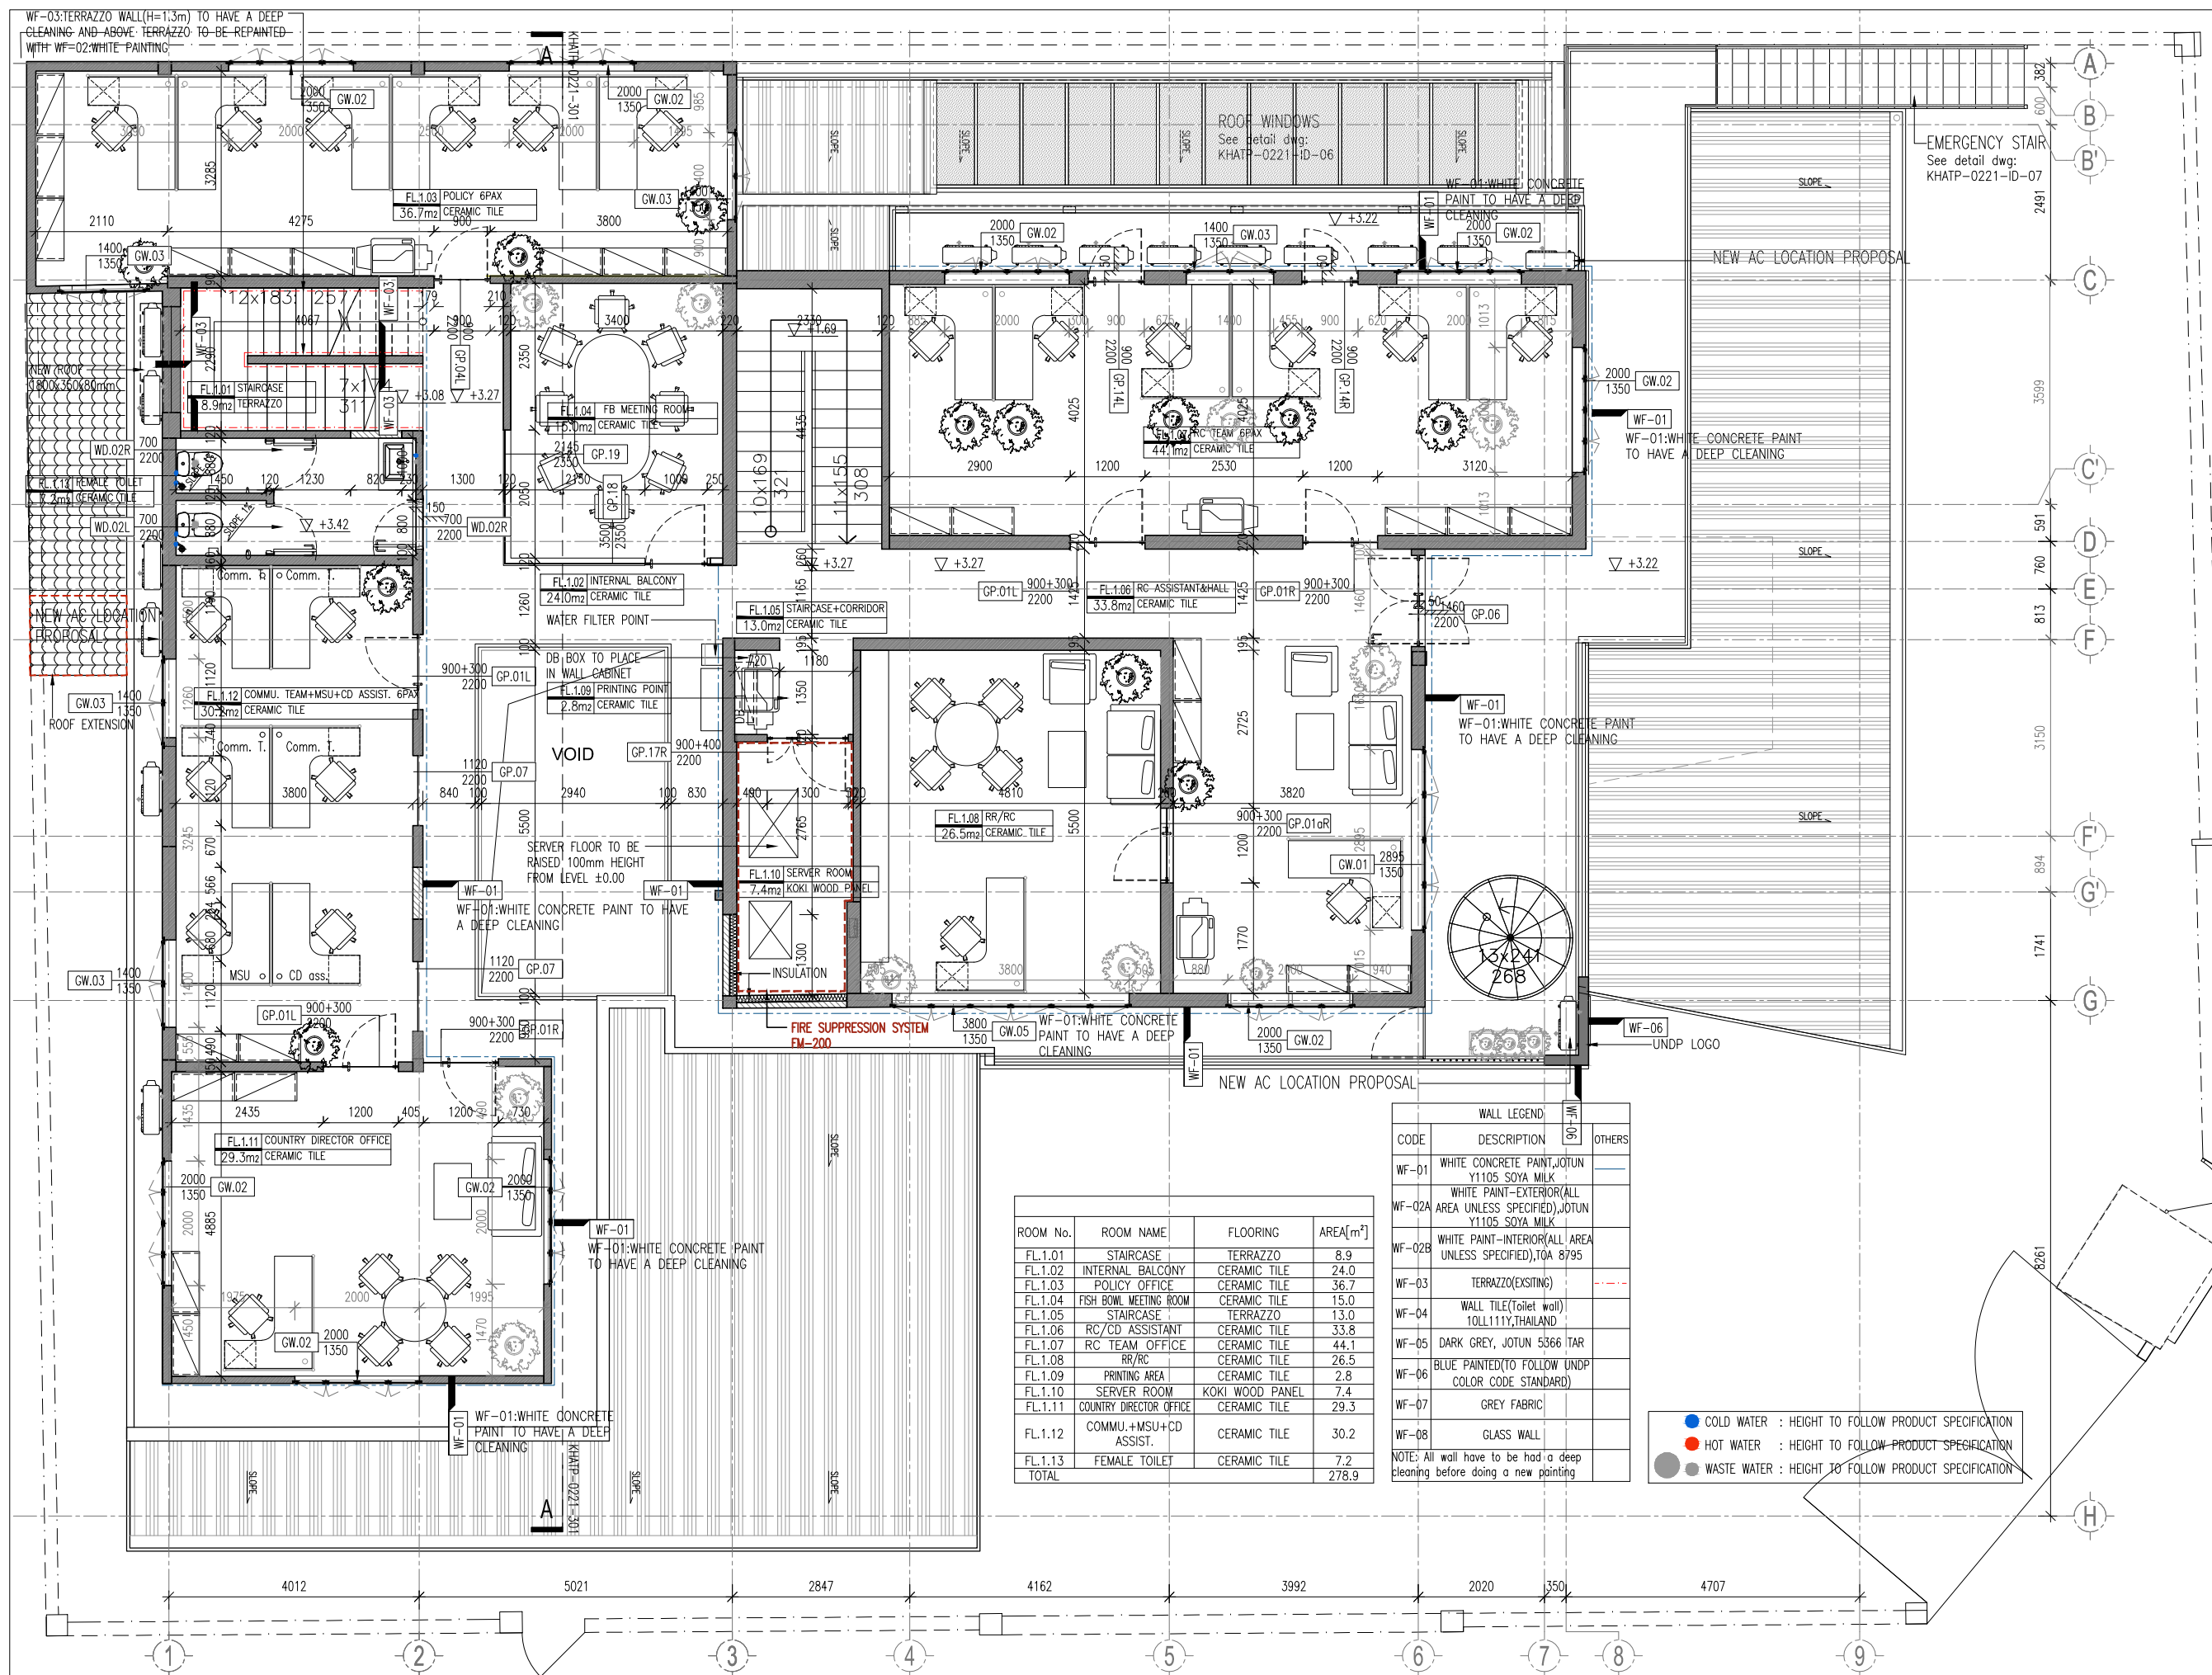

ROOM No.	ROOM NAME	FLOORING	AREA[m ²]
FL.1.01	STAIRCASE	TERRAZZO	8.9
FL.1.02	INTERNAL BALCONY	CERAMIC TILE	24.0
FL.1.03	POLICY OFFICE	CERAMIC TILE	36.7
FL.1.04	FISH BOWL MEETING ROOM	CERAMIC TILE	15.0
FL.1.05	STAIRCASE	TERRAZZO	13.0
FL.1.06	RC/CD ASSISTANT	CERAMIC TILE	33.8
FL.1.07	RC TEAM OFFICE	CERAMIC TILE	44.1
FL.1.08	RR/RC	CERAMIC TILE	26.5
FL.1.09	PRINTING AREA	CERAMIC TILE	2.8
FL.1.10	SERVER ROOM	KOKI WOOD PANEL	7.4
FL.1.11	COUNTRY DIRECTOR OFFICE	CERAMIC TILE	29.3
FL.1.12	COMMU.+MSU+CD ASSIST.	CERAMIC TILE	30.2
FL.1.13	FEMALE TOILET	CERAMIC TILE	7.2
TOTAL			278.9

CODE	DESCRIPTION	OTHERS
WF-01	WHITE CONCRETE PAINT, JOTUN Y1105 SOYA MILK	
WF-02A	WHITE PAINT-EXTERIOR(ALL AREA UNLESS SPECIFIED), JOTUN Y1105 SOYA MILK	
WF-02B	WHITE PAINT-INTERIOR(ALL AREA UNLESS SPECIFIED), TOA 8795	
WF-03	TERRAZZO(EXISTING)	
WF-04	WALL TILE(TOILET WALL) 10LL111Y, THAILAND	
WF-05	DARK GREY, JOTUN 5366 TAR	
WF-06	BLUE PAINTED(TO FOLLOW UNDP COLOR CODE STANDARD)	
WF-07	GREY FABRIC	
WF-08	GLASS WALL	

● COLD WATER : HEIGHT TO FOLLOW PRODUCT SPECIFICATION
● HOT WATER : HEIGHT TO FOLLOW PRODUCT SPECIFICATION
● WASTE WATER : HEIGHT TO FOLLOW PRODUCT SPECIFICATION

PROJECT OWNER
UNDP

THE ROOM

DESIGN STUDIO BY MURAYA

Architecture | Interior Design

Tel: 023 993 620
www.therooms.com

KEY PLAN / NOTE

កំណត់សម្គាល់:

- មិនត្រូវប្រើប្រាស់ផែនទីនេះសម្រាប់ការសាងសង់ ឬការកែសម្រួលប្រសិនបើមានការអនុញ្ញាត
- អ្នកប្រើប្រាស់ត្រូវតែពិនិត្យទិន្នន័យទាំងអស់ មុននឹងចាប់ផ្តើមការងារ
- ប្រសិនបើមានការកែសម្រួល ឬការកែប្រែ ត្រូវតែមានការអនុញ្ញាតពីអ្នករៀបចំផែនទី
- ក្នុងករណីមានការកែសម្រួល ឬការកែប្រែ ត្រូវតែមានការអនុញ្ញាតពីអ្នករៀបចំផែនទី
- ក្នុងករណីមានការកែសម្រួល ឬការកែប្រែ ត្រូវតែមានការអនុញ្ញាតពីអ្នករៀបចំផែនទី
- ក្នុងករណីមានការកែសម្រួល ឬការកែប្រែ ត្រូវតែមានការអនុញ្ញាតពីអ្នករៀបចំផែនទី

WARNING

- This drawing shall not be used for construction unless certified.
- Contractor to verify all dimensions of existing works on site before commencing any work or preparing shop drawings.
- Do not scale drawings, use written dimensions only.
- All measurements in millimeters.
- All levels in meters.
- This drawing is to be read in conjunction with the specifications and conditions of contract.
- This drawing and design are copyright and no portion may be produced without the permission of The Room Design Studio By Muraya.

REVISIONS:

H		
G		
F		
E		
D		
C		
B		
A	Revision 1	2018.04.24

REF: កំណត់សម្គាល់/RemarksDate

អនុម័ត/Project Title:

UNDP

អនុម័ត/Drawing Title:

FIRST FLOOR LAYOUT

ស្ថានភាព/Phase:

● គំនិត/CONCEPT DESIGN

● ផែនទី/DETAILED DESIGN

អនុម័ត/POSITION

អនុម័ត/NAME

អនុម័ត/Director

P.J

អនុម័ត/Project Manager

P.J

អនុម័ត/Checked by

P.J

អនុម័ត/Drawn by

UD

អនុម័ត/Issued for:

អនុម័ត/Issued Date:


09 APRIL 2018

អនុម័ត/Scale:


1/100 (A3)

អនុម័ត/Drawing No:

KHATP-0221_101B

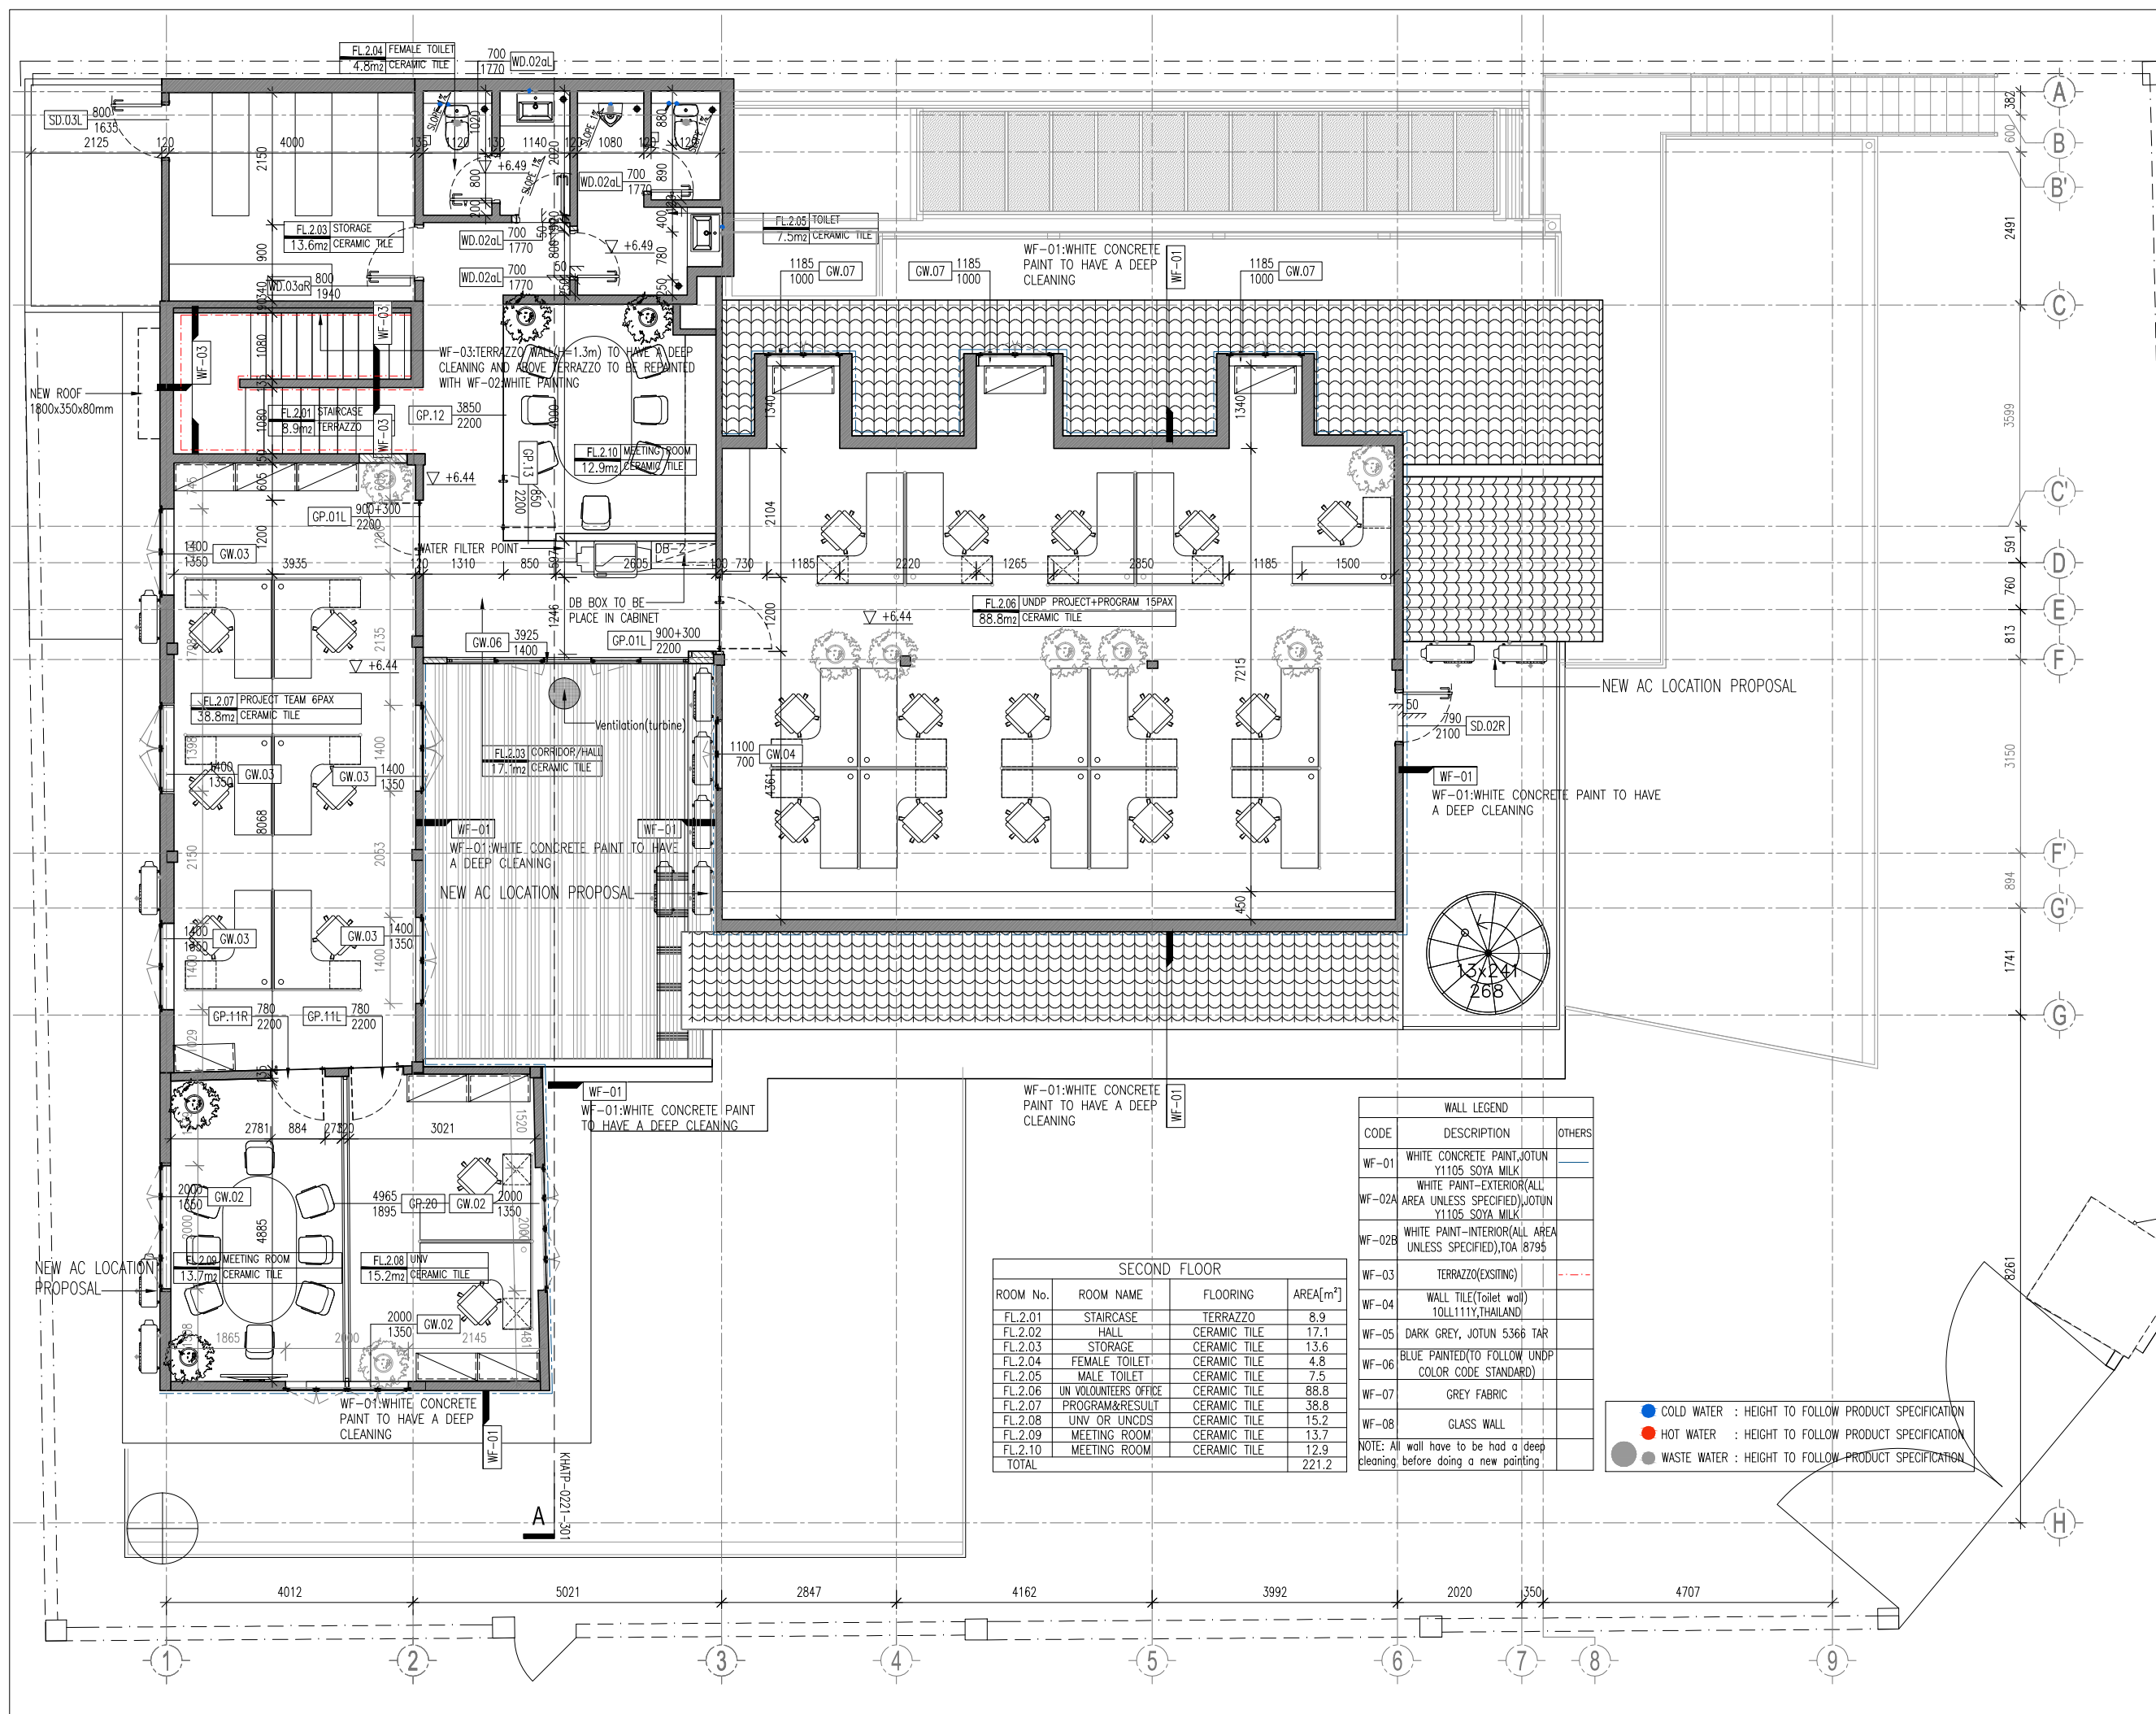

BATHROOM SANITARY		
CODE	DESCRIPTION	OTHER
SA.01	TOILET	
SA.02	TOILET RISING PRAY	
SA.03	TOILET PAPER HOLDER	
SA.04	BASIN	
SA.05	BASIN COUNTER	
SA.06	FAUCET	
SA.07	URINAL	
SA.08	CLOTHES HOOK	
SA.09	TOWEL RING	
SA.10	TOILET FOR DIABLE	
SA.11	SMALL BASIN	
SA.12	HORIZONTAL BAR	
SA.13	VERTICAL BAR	
SA.14A	SMALL MIRROR	
SA.14B	MIRROR FOR DISABLE	
SA.15	FLOOR DRAIN	
SA.16	URINAL FAUCET	
SA.17	SMALL BASIN FAUCET	
TOTAL		

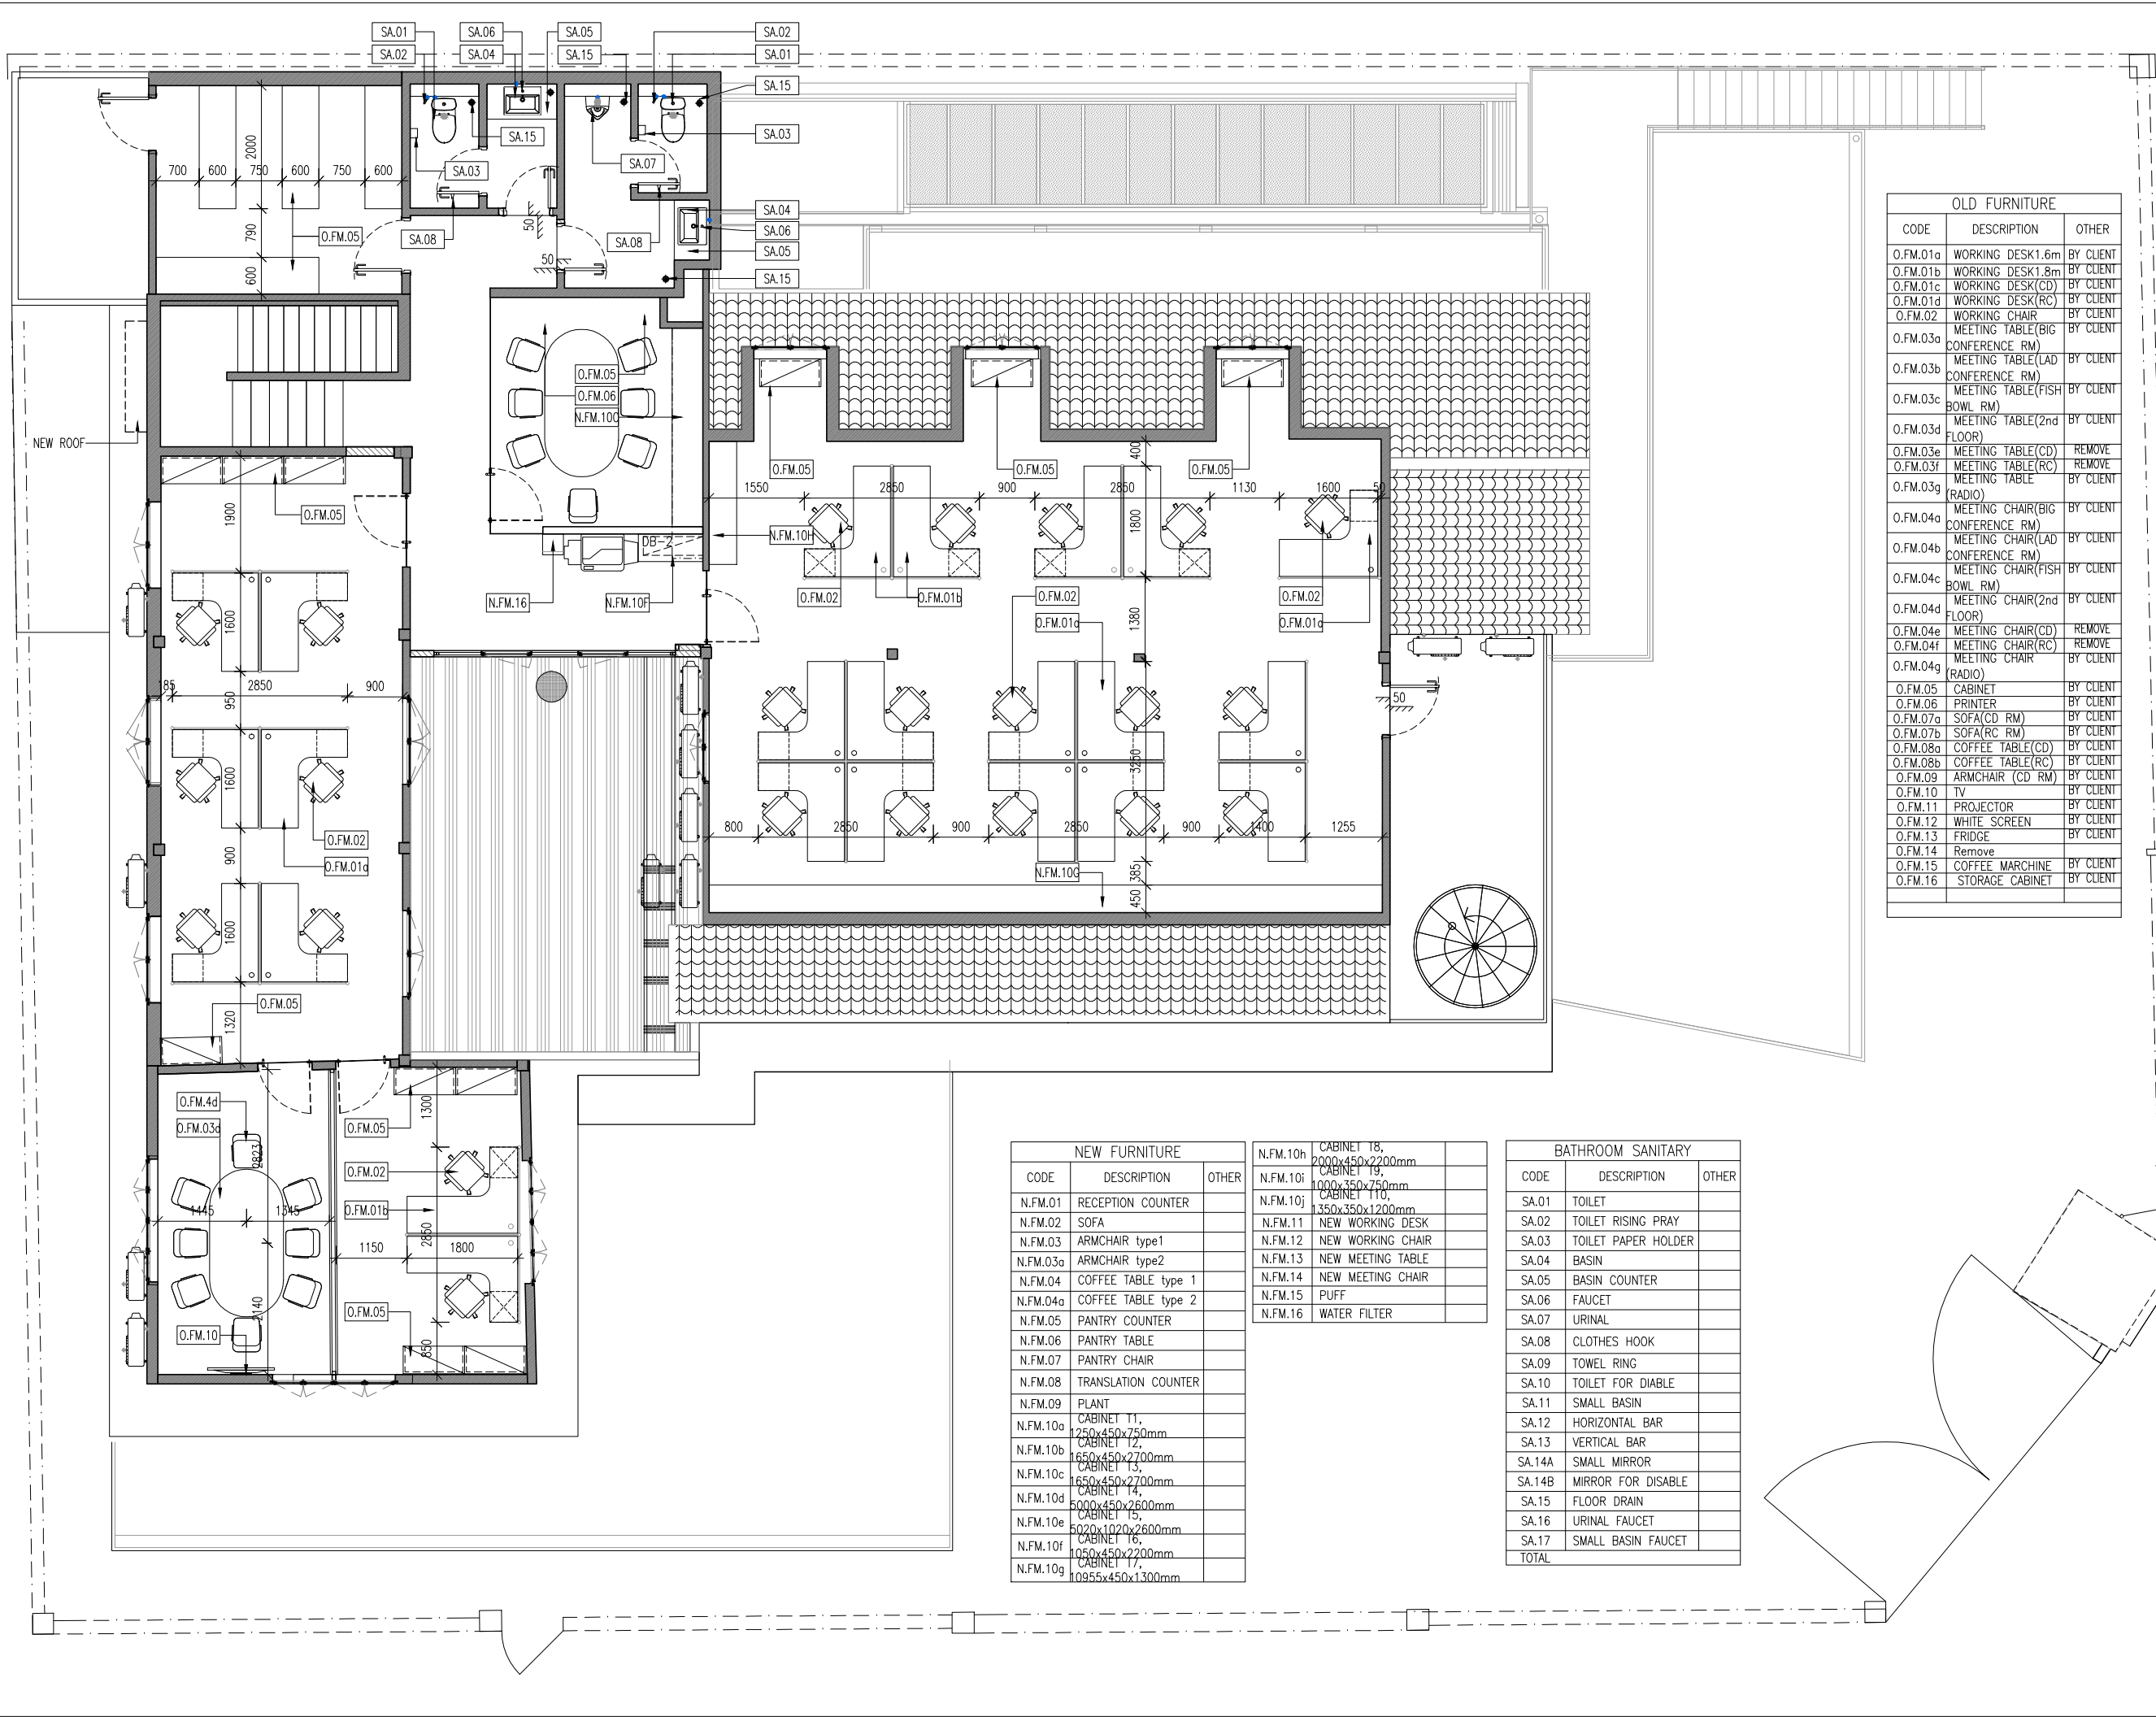

OLD FURNITURE		
CODE	DESCRIPTION	OTHER
O.FM.01a	WORKING DESK1.6m	BY CLIENT
O.FM.01b	WORKING DESK1.8m	BY CLIENT
O.FM.01c	WORKING DESK(CD)	BY CLIENT
O.FM.01d	WORKING DESK(RC)	BY CLIENT
O.FM.02	WORKING CHAIR	BY CLIENT
O.FM.03a	MEETING TABLE(BIG	BY CLIENT
O.FM.03b	CONFERENCE RM)	
O.FM.03c	MEETING TABLE(FISH	BY CLIENT
O.FM.03d	BOWL RM)	
O.FM.03e	MEETING TABLE(2nd	BY CLIENT
O.FM.03f	FLOOR)	
O.FM.03g	MEETING TABLE(CD)	REMOVE
O.FM.03h	MEETING TABLE(RC)	REMOVE
O.FM.03i	MEETING TABLE	BY CLIENT
O.FM.03j	(RADIO)	
O.FM.04a	MEETING CHAIR(BIG	BY CLIENT
O.FM.04b	CONFERENCE RM)	
O.FM.04c	MEETING CHAIR(LAD	BY CLIENT
O.FM.04d	CONFERENCE RM)	
O.FM.04e	MEETING CHAIR(FISH	BY CLIENT
O.FM.04f	BOWL RM)	
O.FM.04g	MEETING CHAIR(2nd	BY CLIENT
O.FM.04h	FLOOR)	
O.FM.04i	MEETING CHAIR(CD)	REMOVE
O.FM.04j	MEETING CHAIR(RC)	REMOVE
O.FM.04k	MEETING CHAIR	BY CLIENT
O.FM.04l	(RADIO)	
O.FM.05	CABINET	BY CLIENT
O.FM.06	PRINTER	BY CLIENT
O.FM.07a	SOFA(CD RM)	BY CLIENT
O.FM.07b	SOFA(RC RM)	BY CLIENT
O.FM.08a	COFFEE TABLE(CD)	BY CLIENT
O.FM.08b	COFFEE TABLE(RC)	BY CLIENT
O.FM.09	ARMCHAIR (CD RM)	BY CLIENT
O.FM.10	TV	BY CLIENT
O.FM.11	PROJECTOR	BY CLIENT
O.FM.12	WHITE SCREEN	BY CLIENT
O.FM.13	FRIDGE	BY CLIENT
O.FM.14	Remove	
O.FM.15	COFFEE MARCHINE	BY CLIENT
O.FM.16	STORAGE CABINET	BY CLIENT

NEW FURNITURE		
CODE	DESCRIPTION	OTHER
N.FM.01	RECEPTION COUNTER	
N.FM.02	SOFA	
N.FM.03	ARMCHAIR type1	
N.FM.03a	ARMCHAIR type2	
N.FM.04	COFFEE TABLE type 1	
N.FM.04a	COFFEE TABLE type 2	
N.FM.05	PANTRY COUNTER	
N.FM.06	PANTRY TABLE	
N.FM.07	PANTRY CHAIR	
N.FM.08	TRANSLATION COUNTER	
N.FM.09	PLANT	
N.FM.10a	CABINET T1,	
N.FM.10b	1250x450x750mm	
N.FM.10c	CABINET T2,	
N.FM.10d	1650x450x700mm	
N.FM.10e	CABINET T3,	
N.FM.10f	1650x450x700mm	
N.FM.10g	CABINET T4,	
N.FM.10h	5000x450x2600mm	
N.FM.10i	CABINET T5,	
N.FM.10j	5020x1020x2600mm	
N.FM.10k	CABINET T6,	
N.FM.10l	1050x450x2200mm	
N.FM.10m	CABINET T7,	
N.FM.10n	10955x450x1300mm	

N.FM.10h	CABINET T8,	
N.FM.10i	2000x450x2200mm	
N.FM.10j	CABINET T9,	
N.FM.10k	1000x350x750mm	
N.FM.10l	CABINET T10,	
N.FM.10m	1350x350x1200mm	
N.FM.11	NEW WORKING DESK	
N.FM.12	NEW WORKING CHAIR	
N.FM.13	NEW MEETING TABLE	
N.FM.14	NEW MEETING CHAIR	
N.FM.15	PUFF	
N.FM.16	WATER FILTER	

BATHROOM SANITARY		
CODE	DESCRIPTION	OTHER
SA.01	TOILET	
SA.02	TOILET RISING PRAY	
SA.03	TOILET PAPER HOLDER	
SA.04	BASIN	
SA.05	BASIN COUNTER	
SA.06	FAUCET	
SA.07	URINAL	
SA.08	CLOTHES HOOK	
SA.09	TOWEL RING	
SA.10	TOILET FOR DIABLE	
SA.11	SMALL BASIN	
SA.12	HORIZONTAL BAR	
SA.13	VERTICAL BAR	
SA.14	SMALL MIRROR	
SA.14B	MIRROR FOR DISABLE	
SA.15	FLOOR DRAIN	
SA.16	URINAL FAUCET	
SA.17	SMALL BASIN FAUCET	
TOTAL		

PROJECT OWNER
UNDP



Architecture | Interior Design

Tel: 023 993 620
www.therooms.com

KEY PLAN / NOTE

កំណត់សម្គាល់:

- មិនត្រូវប្រើប្រាស់ផែនទីនេះសម្រាប់ការសាងសង់ ឬការកែសម្រួលទីតាំងណាមួយ
- អ្នកកាន់កាប់ប្រតិបត្តិការសាងសង់ ឬការកែសម្រួល ត្រូវតែពិនិត្យទីតាំងនេះមុនពេលចាប់ផ្តើមការងារ
- ប្រសិនបើមានការកែសម្រួលទីតាំងណាមួយ ត្រូវតែមានការអនុញ្ញាតពីអ្នកកាន់កាប់ប្រតិបត្តិការសាងសង់ ឬការកែសម្រួល
- រាល់ការកែសម្រួលទីតាំងណាមួយ ត្រូវតែមានការអនុញ្ញាតពីអ្នកកាន់កាប់ប្រតិបត្តិការសាងសង់ ឬការកែសម្រួល
- ប្រសិនបើមានការកែសម្រួលទីតាំងណាមួយ ត្រូវតែមានការអនុញ្ញាតពីអ្នកកាន់កាប់ប្រតិបត្តិការសាងសង់ ឬការកែសម្រួល
- ប្រសិនបើមានការកែសម្រួលទីតាំងណាមួយ ត្រូវតែមានការអនុញ្ញាតពីអ្នកកាន់កាប់ប្រតិបត្តិការសាងសង់ ឬការកែសម្រួល

WARNING
- This drawing shall not be used for construction unless certified.
- Contractor to verify all dimensions of existing works on site before commencing any work or preparing shop drawings.
- Do not scale drawings, use written dimensions only.
- All measurements in millimeters.
- All levels in meters.
- This drawing is to be read in conjunction with the specifications and conditions of contract.
- This drawing and design are copyright and no portion may be produced without the permission of The Room Design Studio By Muraya.

REVISIONS:

H		
G		
F		
E		
D		
C		
B		
A		
REF:	កំណត់សម្គាល់/Remarks	Date

ឈ្មោះ/Project Title:

UNDP

ឈ្មោះ/Drawing Title:

FLOOR FINISHES
SECOND FLOOR LAYOUT

ស្ថានភាព/Phase:

- ☐ គំរូ/CONCEPT DESIGN
- ☒ ប្រតិបត្តិ/DETAILED DESIGN

ប្រតិបត្តិ/POSITION	ឈ្មោះ/NAME
អគ្គនាយក/Director	P.J
ប្រធានក្រុមប្រឹក្សាប្រតិបត្តិ/Project Manager	P.J
ត្រួតពិនិត្យ/Checked by:	P.J
គូររូប/Drawn by:	UD

ឈ្មោះ/Issued for:

ចេញផ្សាយ/Issued Date: 09 APRIL 2018
មាត្រដ្ឋាន/Scale: 1/100 (A3)
លេខគម្រោង/Drawing No: KHATP-0221_102C



THE ROOM
DESIGN STUDIO BY MURAYA


[illegible]

WARNING

- This drawing shall not be used for construction unless certified.
- Contractor to verify all dimensions of existing works on site before commencing any work or preparing shop drawings.
 - Do not scale drawings, use written dimensions only.
- All measurements in millimeters.
- All levels in meters.
- This drawing is to be read in conjunction with the specifications and conditions of contract.
- This drawing and design are copyright and no portion may be produced without the permission of **The Room Design Studio By Kurya.**

H		
G		
F		
E		
D		
C		
B		
A	-----	-----
REF.	Final Sales / Remarks	Date

ចេញថ្ងៃ/Issued Date: 09 APRIL 2018	មាត្រដ្ឋាន/Scale: 1/100 (A3)
លេខសម្គាល់/Drawing No: KHATP-0221_103A	

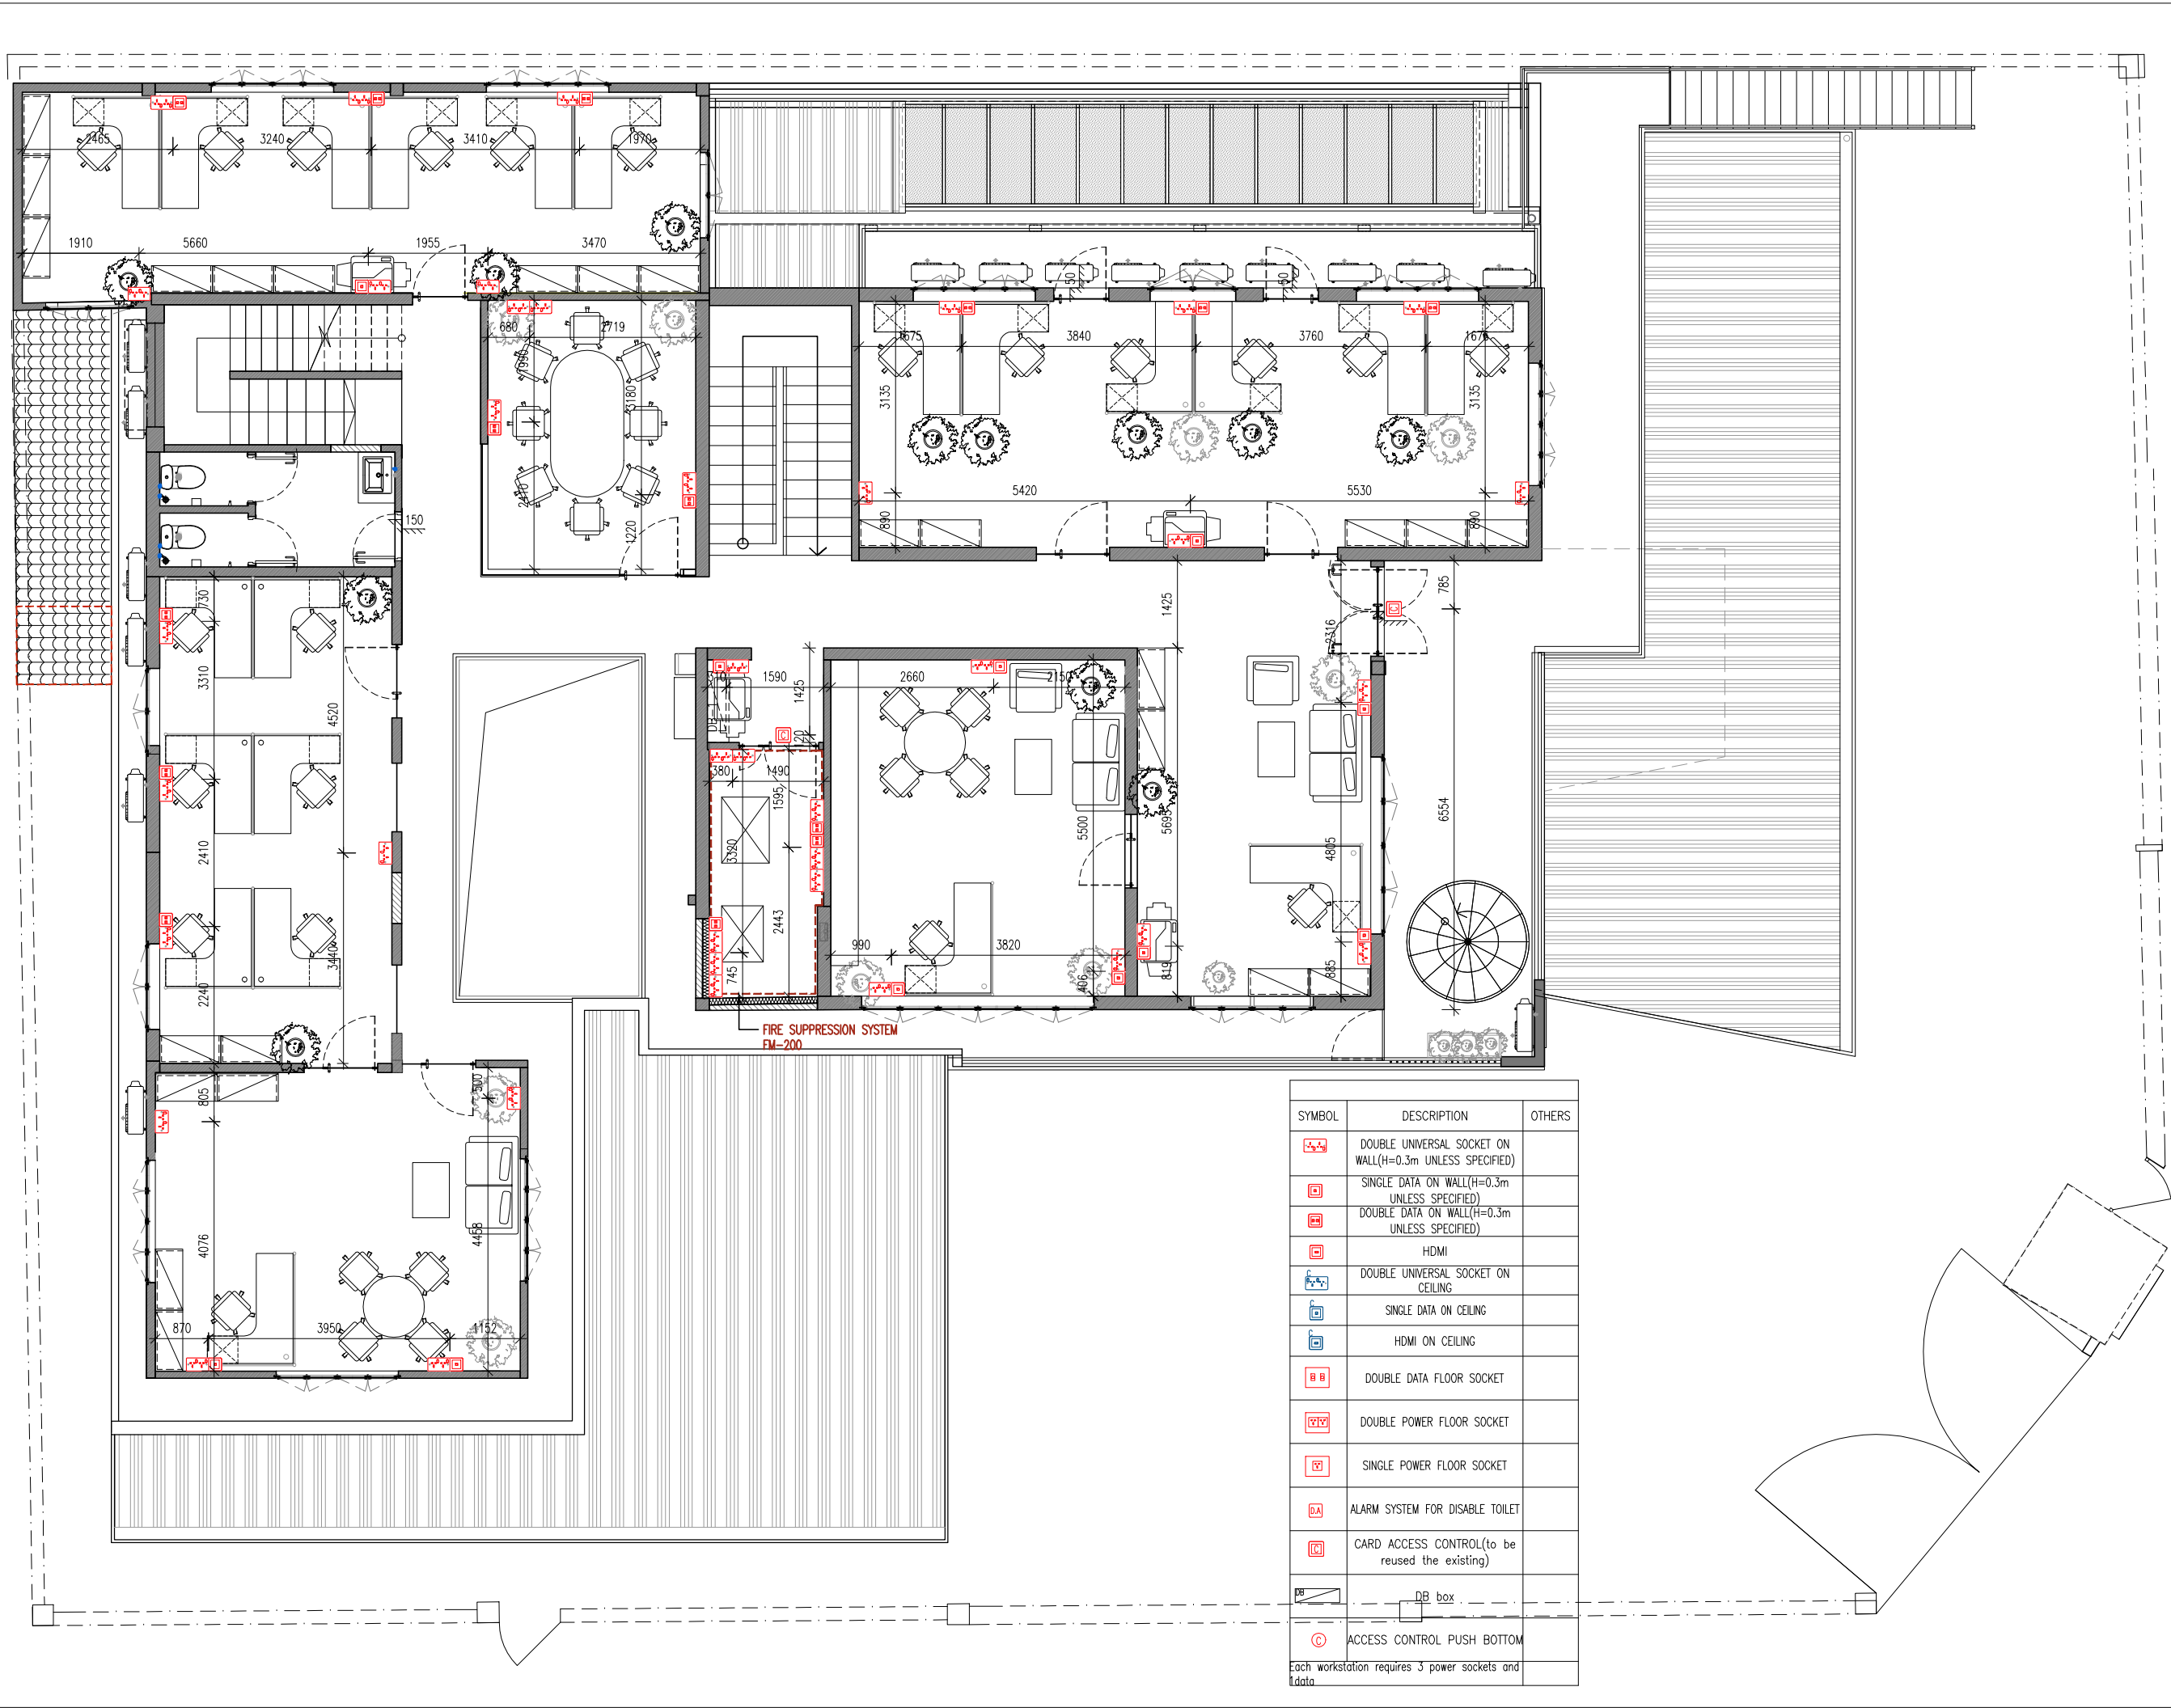

SYMBOL	DESCRIPTION	OTHERS
	DOUBLE UNIVERSAL SOCKET ON WALL(H=0.3m UNLESS SPECIFIED)	
	SINGLE DATA ON WALL(H=0.3m UNLESS SPECIFIED)	
	DOUBLE DATA ON WALL(H=0.3m UNLESS SPECIFIED)	
	HDMI	
	DOUBLE UNIVERSAL SOCKET ON CEILING	
	SINGLE DATA ON CEILING	
	HDMI ON CEILING	
	DOUBLE DATA FLOOR SOCKET	
	DOUBLE POWER FLOOR SOCKET	
	SINGLE POWER FLOOR SOCKET	
	ALARM SYSTEM FOR DISABLE TOILET	
	CARD ACCESS CONTROL(to be reused the existing)	
	DB box	
	ACCESS CONTROL PUSH BOTTOM	

Each workstation requires 3 power sockets and 1 data

PROJECT OWNER
UNDP

THE ROOM

DESIGN STUDIO BY MURAYA

Architecture | Interior Design

Tel: 023 993 620
www.therooms.com

KEY PLAN / NOTE

កំណត់សម្គាល់:

- មិនត្រូវប្រើប្រាស់ផែនទីនេះសម្រាប់ការសាងសង់ ឬការកែសម្រួល ទាំងអស់នៃការសាងសង់
- អ្នកប្រតិបត្តិការសាងសង់ ត្រូវត្រួតពិនិត្យទៅលើការដាក់ទីតាំង មុនពេលចាប់ផ្តើមការសាងសង់
- ប្រសិនបើមានការកែសម្រួល ឬការកែប្រែ ត្រូវតែមានការអនុញ្ញាតពីអ្នកប្រតិបត្តិការសាងសង់
- រាល់ការកែសម្រួល ត្រូវតែមានការអនុញ្ញាតពីអ្នកប្រតិបត្តិការសាងសង់
- រាល់ការកែសម្រួល ត្រូវតែមានការអនុញ្ញាតពីអ្នកប្រតិបត្តិការសាងសង់
- ប្រសិនបើមានការកែសម្រួល ឬការកែប្រែ ត្រូវតែមានការអនុញ្ញាតពីអ្នកប្រតិបត្តិការសាងសង់
- ផែនទីនេះ ត្រូវតែមានការអនុញ្ញាតពីអ្នកប្រតិបត្តិការសាងសង់

WARNING

- This drawing shall not be used for construction unless certified.
- Contractor to verify all dimensions of existing works on site before commencing any work or preparing shop drawings.
- Do not scale drawings, use written dimensions only.
- All measurements in millimeters.
- All levels in meters.
- This drawing is to be read in conjunction with the specifications and conditions of contract.
- This drawing and design are copyright and no portion may be produced without the permission of The Room Design Studio By Muraya.

REVISIONS:

H		
G		
F		
E		
D		
C		
B		
A		

REF: កំណត់សម្គាល់/RemarksDate

ឈ្មោះគម្រោង/Project Title:
UNDP

ឈ្មោះរូប/Drawing Title:
SOCKET AND DATA
FIRST FLOOR LAYOUT


ស្ថានភាពគម្រោង/Phase:
☒ ប្រតិបត្តិការ/CONCEPT DESIGN
☐ ប្រតិបត្តិការ/DETAILED DESIGN

អ្នកប្រតិបត្តិការ/POSITION	ឈ្មោះ/NAME
អគ្គនាយក/Director:	P.J
ប្រធានគម្រោង/Project Manager:	P.J
ត្រួតពិនិត្យ/Checked by:	P.J
ទាញរូប/Drawn by:	UD

ឈ្មោះ/Issued for:

ចេញផ្សាយ/Issued Date: 09 APRIL 2018ច្បាប់/Scale: 1/100 (A3)

លេខគម្រោង/Drawing No: KHATP-0221_103B

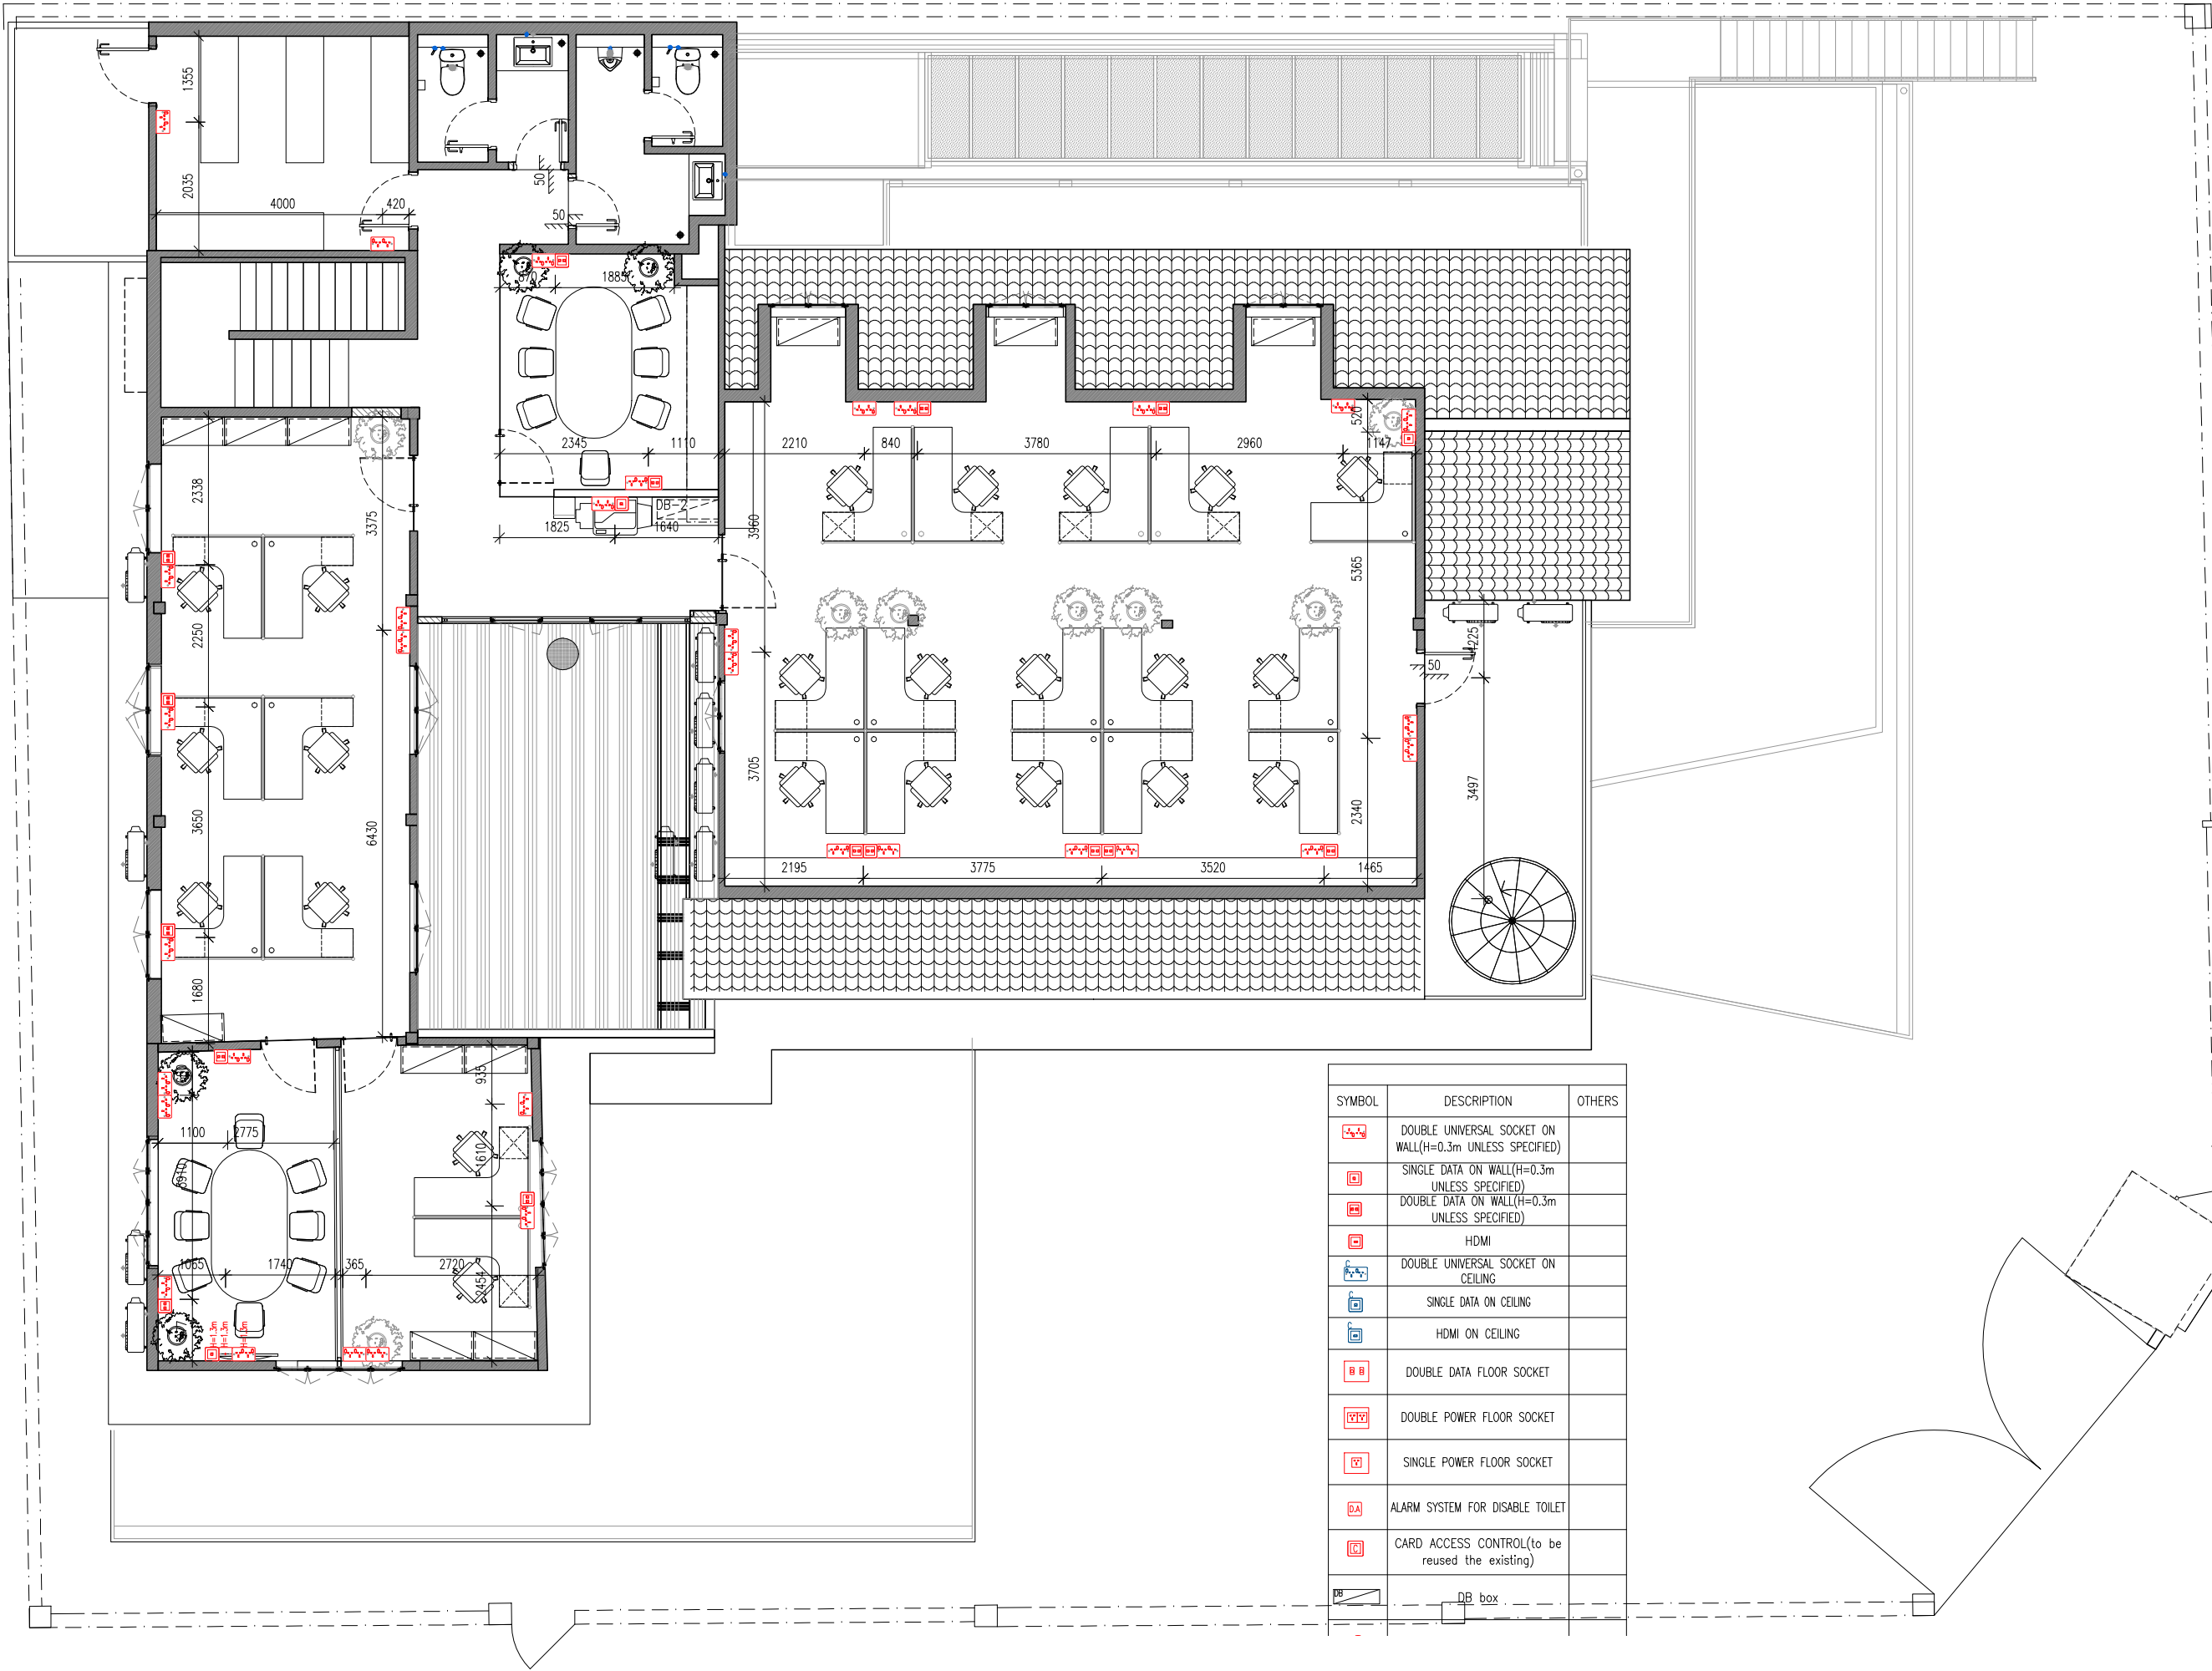

SYMBOL	DESCRIPTION	OTHERS
	DOUBLE UNIVERSAL SOCKET ON WALL(H=0.3m UNLESS SPECIFIED)	
	SINGLE DATA ON WALL(H=0.3m UNLESS SPECIFIED)	
	DOUBLE DATA ON WALL(H=0.3m UNLESS SPECIFIED)	
	HDMI	
	DOUBLE UNIVERSAL SOCKET ON CEILING	
	SINGLE DATA ON CEILING	
	HDMI ON CEILING	
	DOUBLE DATA FLOOR SOCKET	
	DOUBLE POWER FLOOR SOCKET	
	SINGLE POWER FLOOR SOCKET	
	ALARM SYSTEM FOR DISABLE TOILET	
	CARD ACCESS CONTROL(to be reused the existing)	
	DB box	

PROJECT OWNER
UNDP

THE ROOM

DESIGN STUDIO BY MURAYA

Architecture | Interior Design

Tel: 023 993 620
www.theroomds.com

KEY PLAN / NOTE

កំណត់សម្គាល់:

- មិនត្រូវប្រើប្រាស់ផែនទីនេះសម្រាប់ការសាងសង់ ឬការកែសម្រួល ទាំងនេះគឺជាផែនទីសម្រាប់ប្រើប្រាស់ប៉ុណ្ណោះ
- អ្នកកសាងត្រូវត្រួតពិនិត្យទៅលើការកសាង ឬការកែសម្រួល មុនពេលចាប់ផ្តើមការងារ
- ប្រសិនបើមានការកែសម្រួល ឬការកសាង ត្រូវតែមានការអនុញ្ញាតពីអ្នករៀបចំផែនទីនេះ
- រាល់ការកែសម្រួលត្រូវតែធ្វើឡើងតាមការណែនាំ
- ប្រសិនបើមានការកែសម្រួល ឬការកសាង ត្រូវតែមានការអនុញ្ញាតពីអ្នករៀបចំផែនទីនេះ
- ផែនទីនេះគឺជាផែនទីសម្រាប់ប្រើប្រាស់ប៉ុណ្ណោះ មិនមែនជាផែនទីសម្រាប់ប្រើប្រាស់ផ្សេងទៀត
- ការអនុញ្ញាតត្រូវបានផ្តល់ឲ្យអ្នករៀបចំផែនទីនេះ **The Room Design Studio By Muraya.**

WARNING

- This drawing shall not be used for construction unless certified.
- Contractor to verify all dimensions of existing works on site before commencing any work or preparing shop drawings.
- Do not scale drawings, use written dimensions only.
- All measurements in millimeters.
- All levels in meters.
- This drawing is to be read in conjunction with the specifications and conditions of contract.
- This drawing and design are copyright and no portion may be produced without the permission of **The Room Design Studio By Muraya.**

REVISIONS:

H		
G		
F		
E		
D		
C		
B		
A		

REF:	កំណត់សម្គាល់/Remarks	Date
------	----------------------	------

Project Title:
UNDP


Drawing Title:
SOCKET AND DATA
SECOND FLOOR LAYOUT

Phase:
☒ ប្រតិបត្តិការ/CONCEPT DESIGN
☐ ប្រតិបត្តិការ/DETAILED DESIGN

ប្រតិបត្តិការ/POSITION	ឈ្មោះ/NAME
អគ្គនាយក/Director:	P.J
ប្រធានក្រុមប្រឹក្សាប្រចាំ /Project Manager:	P.J
ត្រួតពិនិត្យ/Checked by:	P.J
គូររូប/Drawn by:	UD

ឈ្មោះ/Issued for:

ចេញផ្សាយ/Issued Date: 09 APRIL 2018	មាត្រដ្ឋាន/Scale: 1/100 (A3)
លេខផ្សាយ/Drawing No: KHATP-0221_103C	

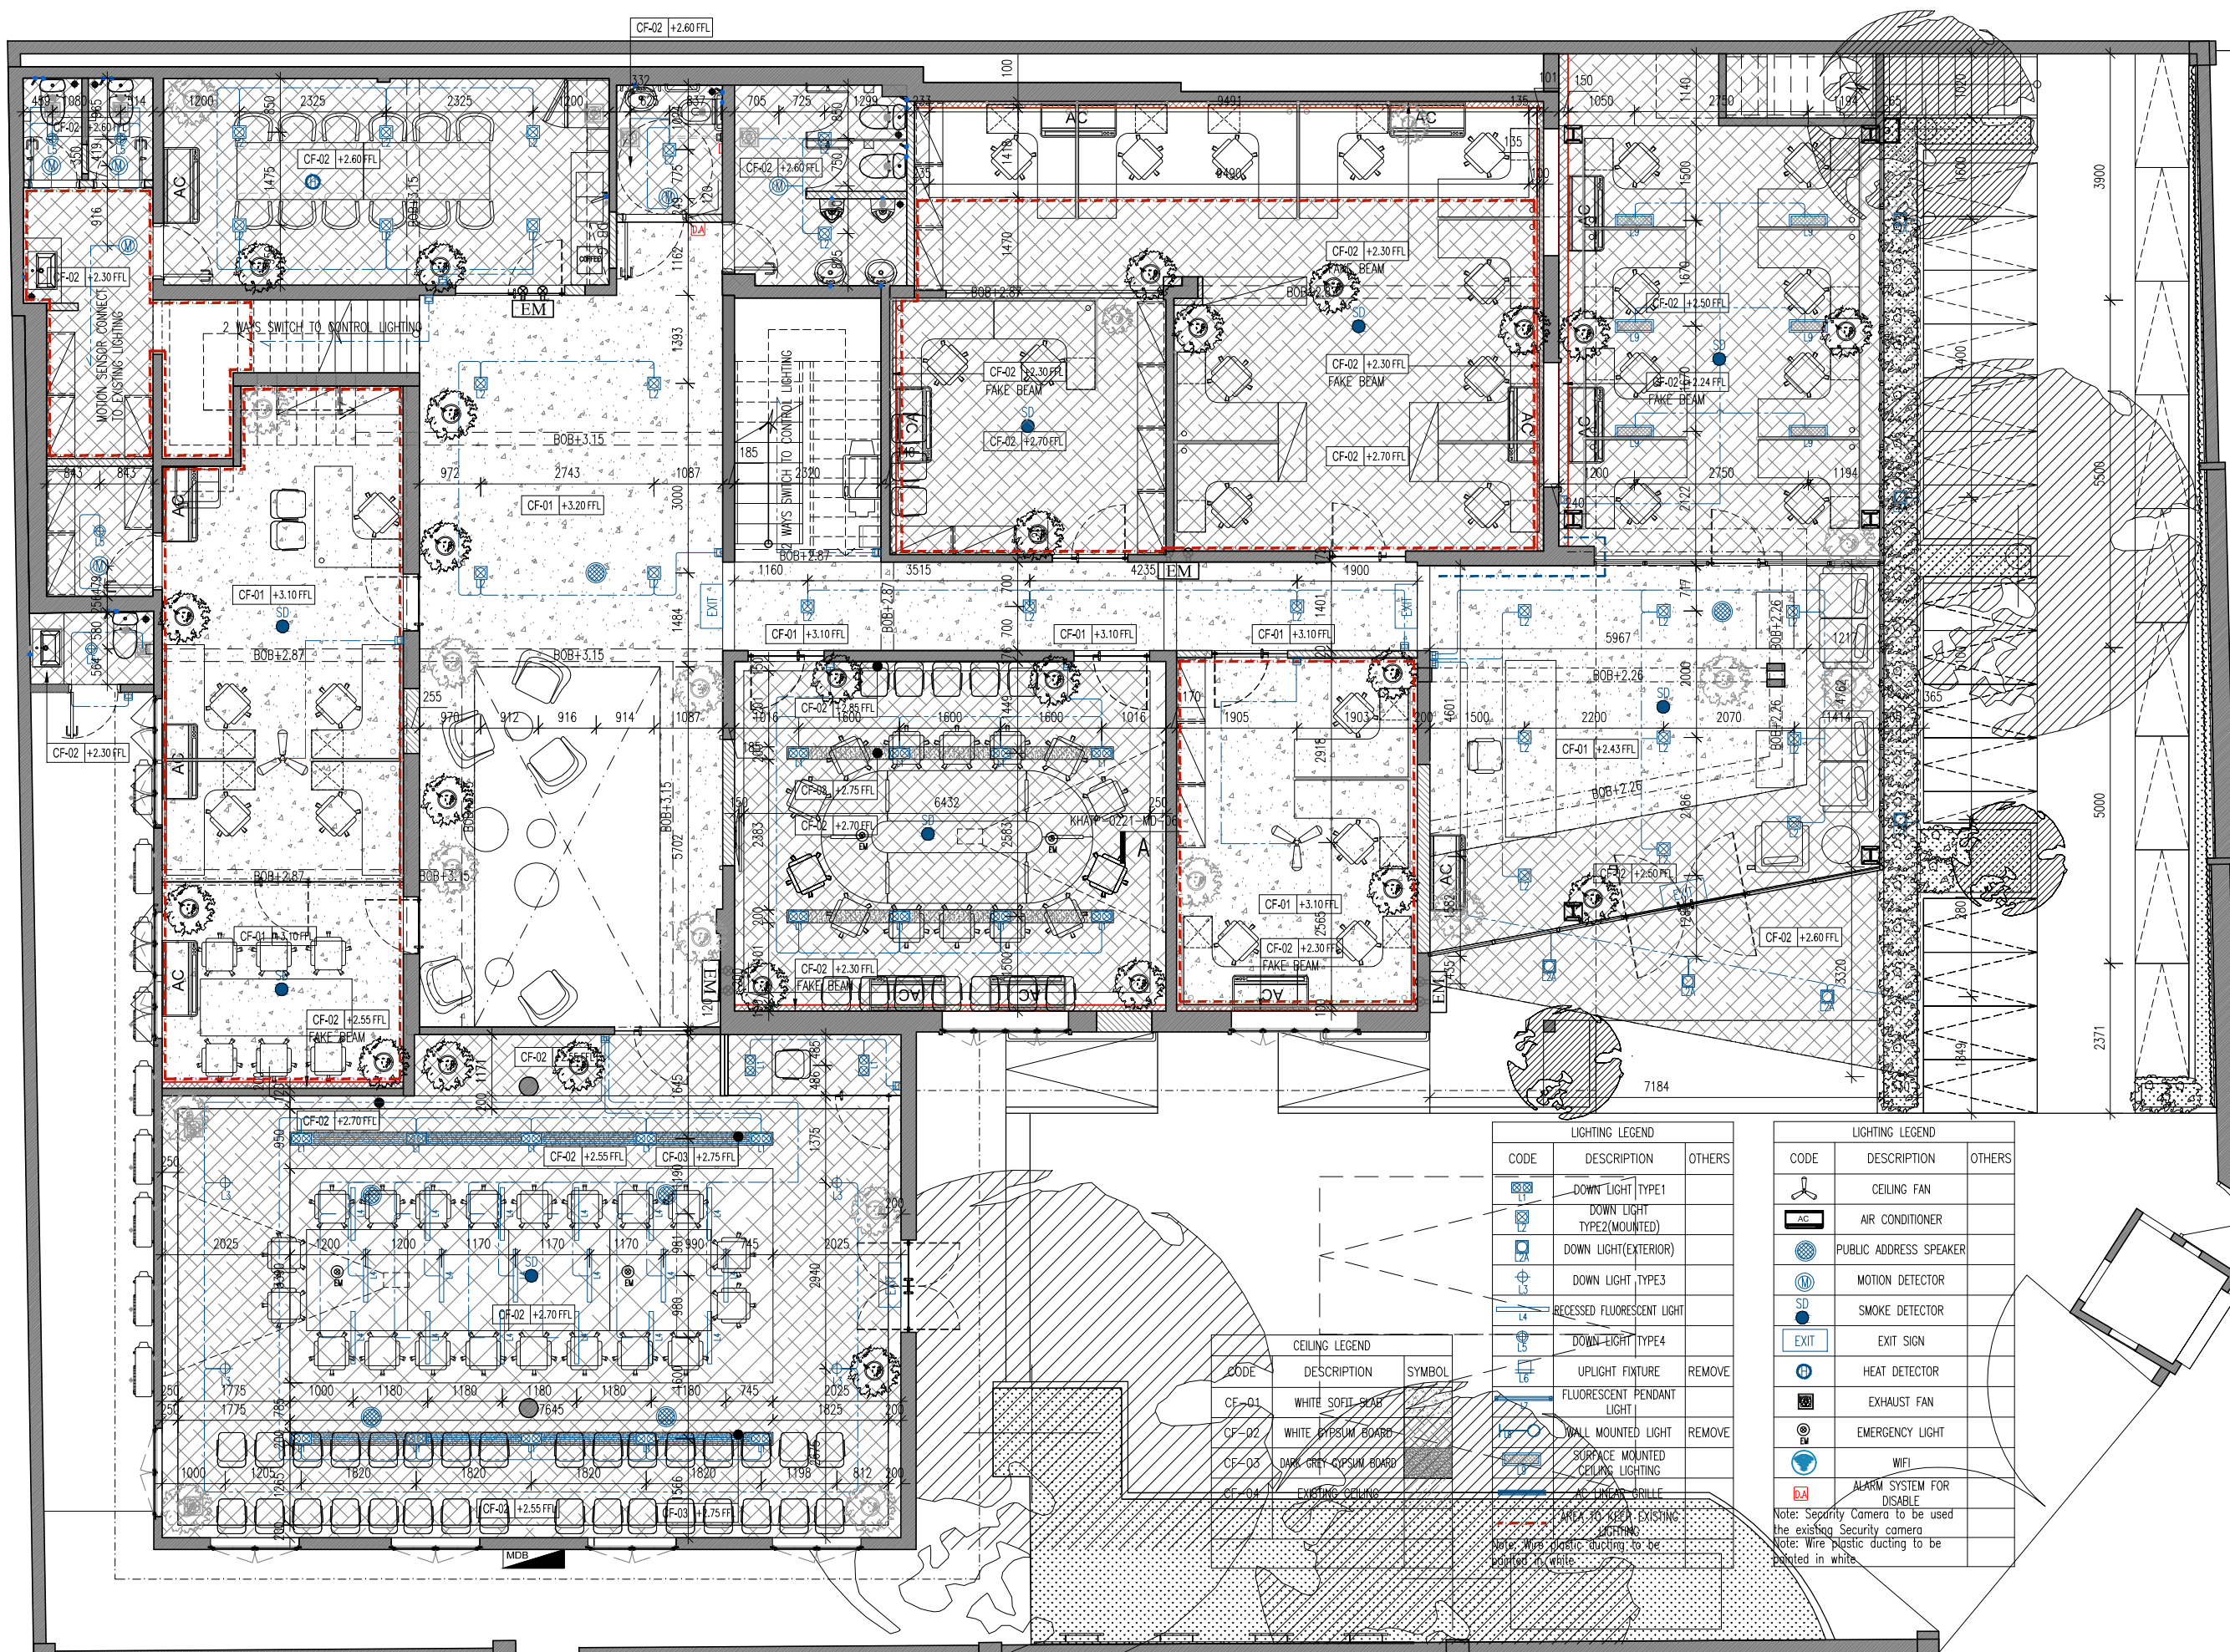

PROJECT OWNER
UNDP

THE ROOM

DESIGN STUDIO BY MURAYA

Architecture | Interior Design
Tel: 023 993 620
www.therooms.com

KEY PLAN / NOTE

កំណត់សម្គាល់:

- មិនត្រូវប្រើប្រាស់ផែនទីនេះសម្រាប់ការសាងសង់ឡើយ ពួកគេត្រូវតែមានការអនុញ្ញាត

- ម្ចាស់គម្រោងត្រូវតែពិនិត្យផែនទីនេះមុនពេលប្រើប្រាស់ ដើម្បីជៀសវាងការកំហុស

- មិនអាចទាមទារបានថាផែនទីនេះត្រឹមត្រូវ ព្រោះវាអាចមានការកំហុស ឬមានការកែប្រែ

- មិនអាចទាមទារបានថាផែនទីនេះត្រឹមត្រូវ ព្រោះវាអាចមានការកំហុស ឬមានការកែប្រែ

WARNING

- This drawing shall not be used for construction unless certified.

- Contractor to verify all dimensions of existing works on site before commencing any work or preparing shop drawings.

- Do not scale drawings, use written dimensions only.

- All measurements in millimeters.

- All levels in meters.

- This drawing is to be read in conjunction with the specifications and conditions of contract.

- This drawing and design are copyright and no portion may be produced without the permission of The Room Design Studio By Muraya.

REVISIONS:

H		
G		
F		
E		
D		
C		
B		
A	Revision 1	2018.04.24

REF: កំណត់សម្គាល់/Remarks

Date

UNDP

ក្រុមហ៊ុន/Project Title:

ក្រុមហ៊ុន/Drawing Title:

CEILING AND LIGHTING
GROUND FLOOR LAYOUT

កំណត់សម្គាល់/Phase:

☐ គម្រោង/CONCEPT DESIGN

☐ គម្រោង/DETAILED DESIGN

មុខតំណែង/POSITION	ឈ្មោះ/NAME
អគ្គនាយក/Director:	P.J
ប្រធានគម្រោង/Project Manager:	P.J
វិធានការ/Checked by:	P.J
គូរផែនទី/Drawn by:	UD

អនុញ្ញាត/Issued for:


អនុញ្ញាត/Issued Date:
09 APRIL 2018

មាត្រដ្ឋាន/Scale:
1/100 (A3)

លេខផែនទី/Drawing No:
KHATP-0221_104A

LIGHTING LEGEND		
CODE	DESCRIPTION	OTHER
	CEILING FAN	
	AIR CONDITIONER	
	PUBLIC ADDRESS SPEAKER	
	MOTION DETECTOR	
	SMOKE DETECTOR	
	EXIT SIGN	
	HEAT DETECTOR	
	EXHAUST FAN	
	EMERGENCY LIGHT	
	WIFI	
	ALARM SYSTEM FOR DISABLE	

Note: Security Camera to be used the existing Security camera
 Note: Wire plastic ducting to be painted in white

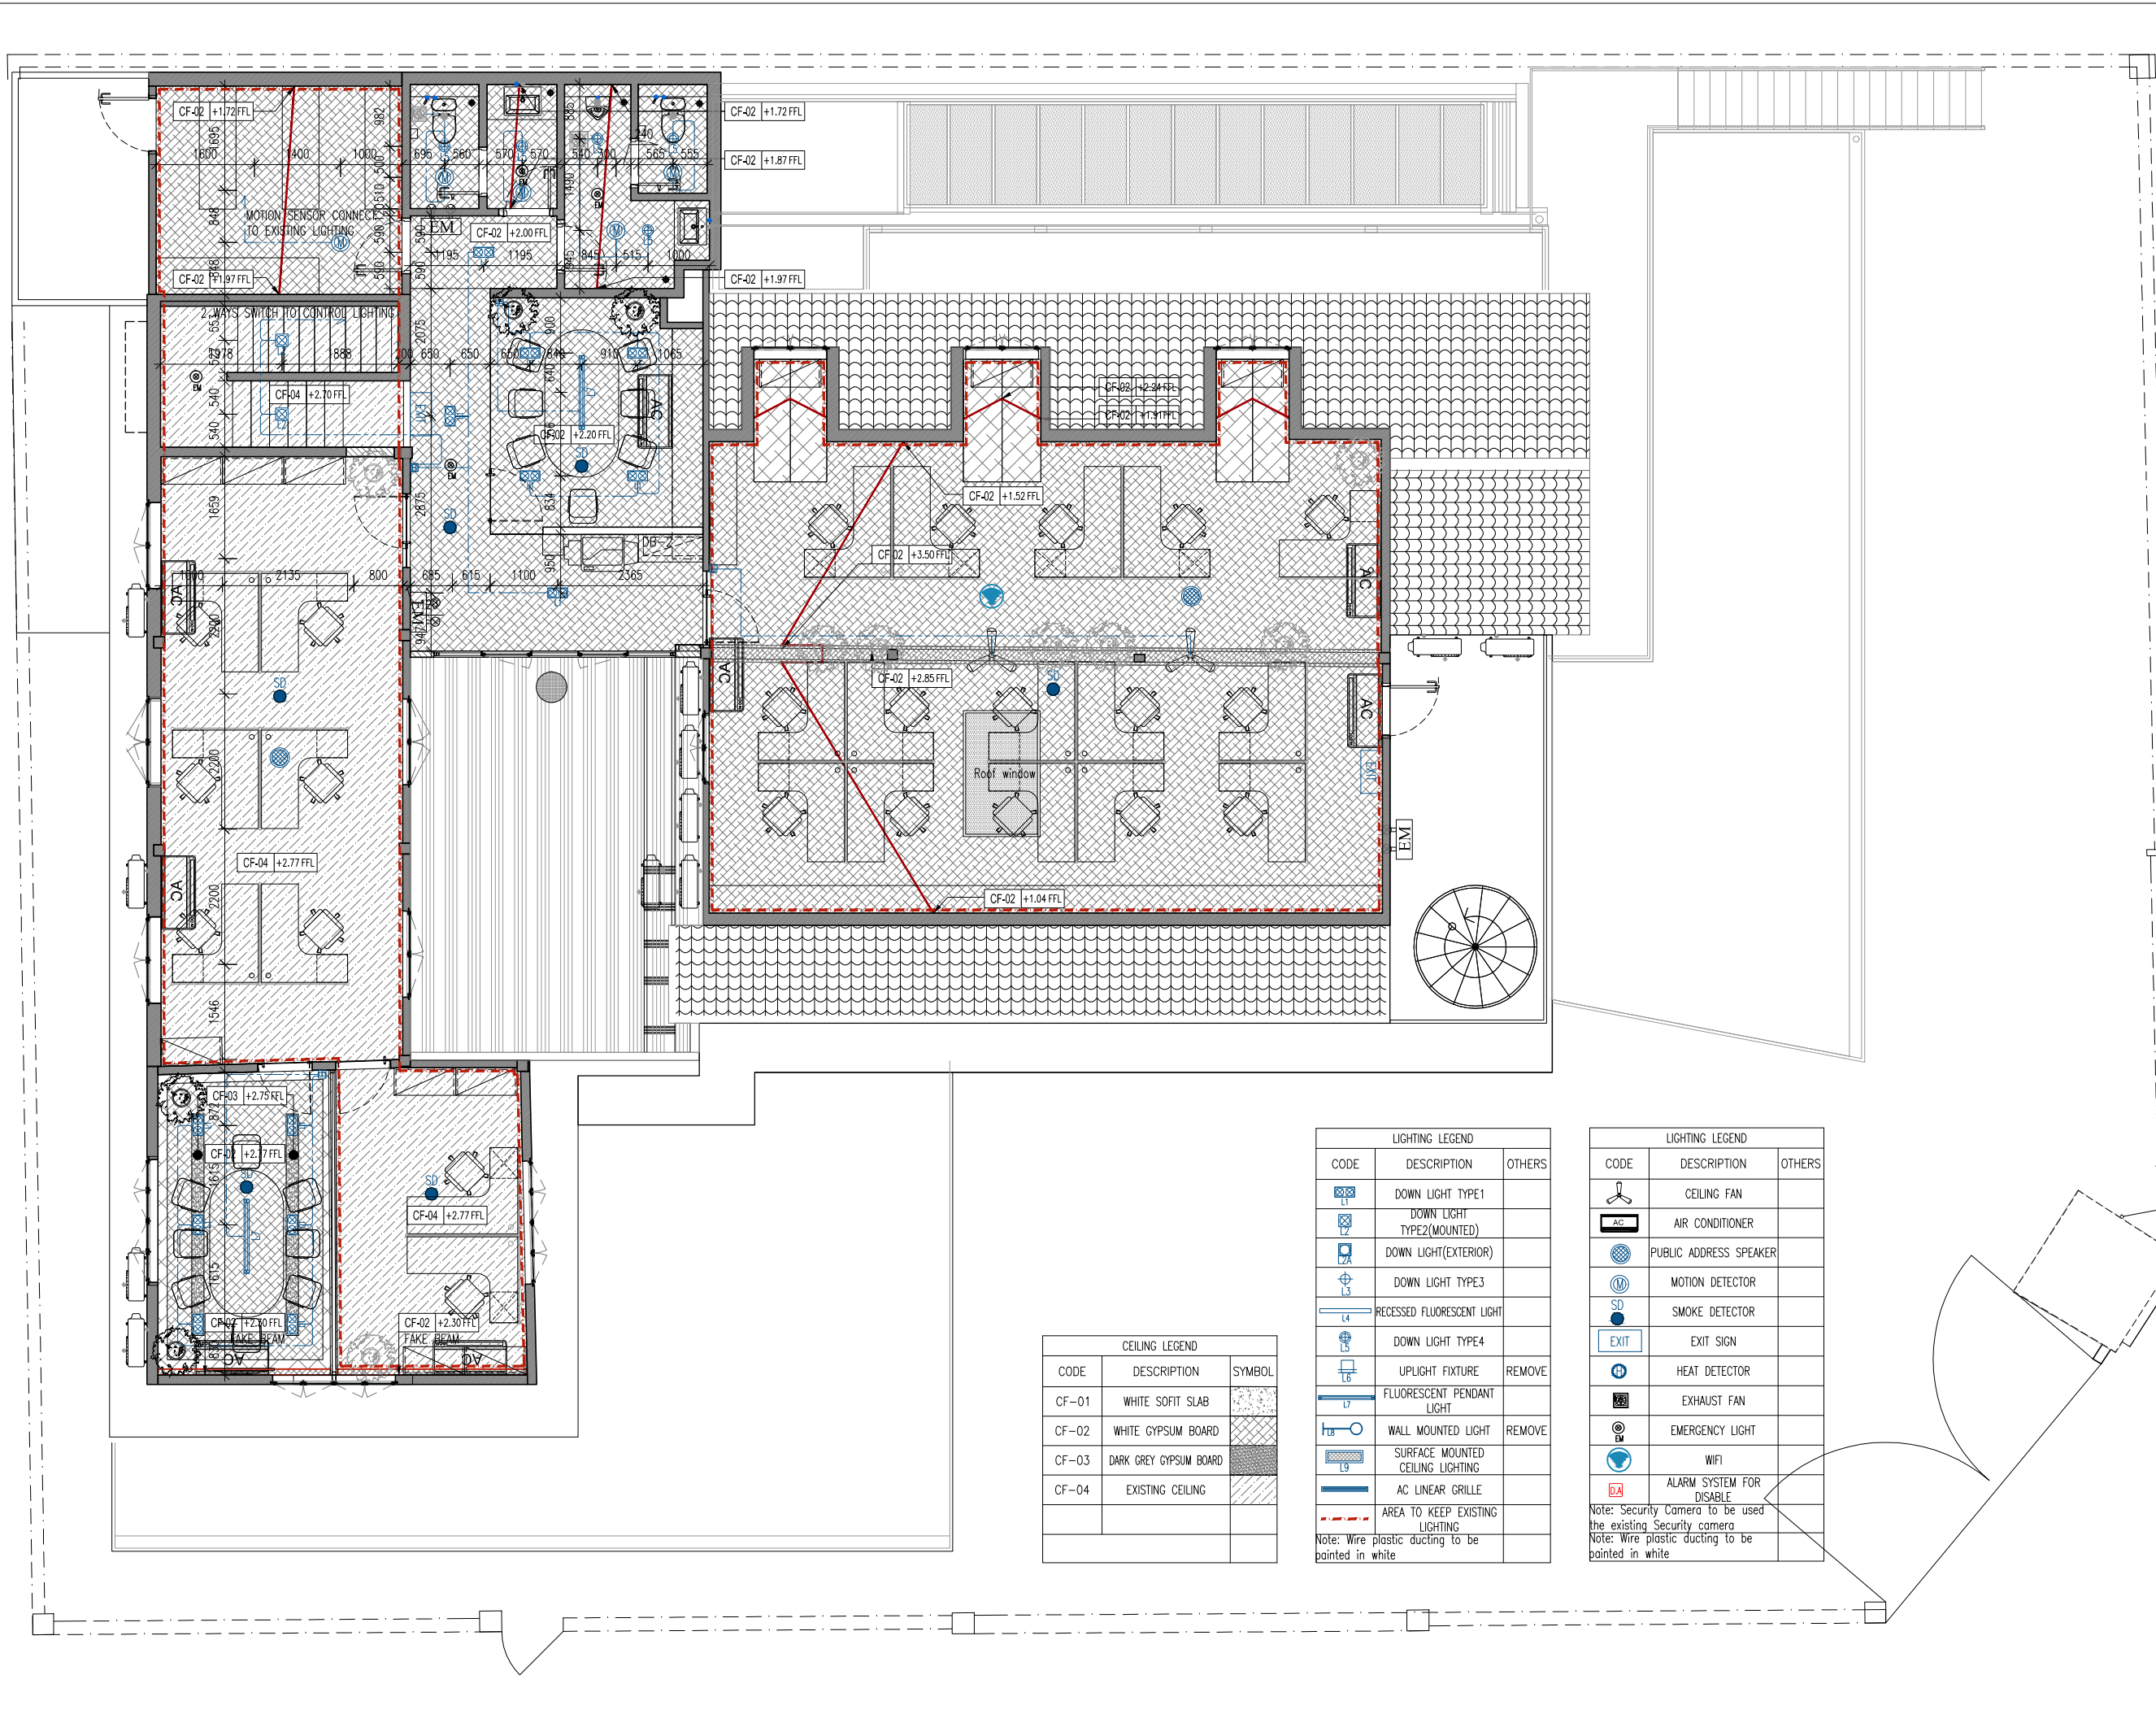

CEILING LEGEND		
CODE	DESCRIPTION	SYMBOL
CF-01	WHITE SOFT SLAB	
CF-02	WHITE GYPSUM BOARD	
CF-03	DARK GREY GYPSUM BOARD	
CF-04	EXISTING CEILING	

LIGHTING LEGEND		
CODE	DESCRIPTION	OTHERS
	DOWN LIGHT TYPE1	
	DOWN LIGHT TYPE2(MOUNTED)	
	DOWN LIGHT(EXTERIOR)	
	DOWN LIGHT TYPE3	
	RECESSED FLUORESCENT LIGHT	
	DOWN LIGHT TYPE4	
	UPLIGHT FIXTURE	REMOVE
	FLUORESCENT PENDANT LIGHT	
	WALL MOUNTED LIGHT	REMOVE
	SURFACE MOUNTED CEILING LIGHTING	
	AC LINEAR GRILLE	
	AREA TO KEEP EXISTING LIGHTING	
Note: Wire plastic ducting to be painted in white		

LIGHTING LEGEND		
CODE	DESCRIPTION	OTHERS
	CEILING FAN	
	AIR CONDITIONER	
	PUBLIC ADDRESS SPEAKER	
	MOTION DETECTOR	
	SMOKE DETECTOR	
	EXIT SIGN	
	HEAT DETECTOR	
	EXHAUST FAN	
	EMERGENCY LIGHT	
	WIFI	
	ALARM SYSTEM FOR DISABLE	
Note: Security Camera to be used the existing Security camera		
Note: Wire plastic ducting to be painted in white		

PROJECT OWNER
UNDP

THE ROOM

DESIGN STUDIO BY MURAYA

Architecture | Interior Design

Tel: 023 993 620
www.therooms.com

KEY PLAN / NOTE

កំណត់សម្គាល់:

- មិនត្រូវប្រើប្រាស់ផែនទីនេះសម្រាប់ការសាងសង់ ឬការកែសម្រួល បន្ទាប់ពីការអនុម័ត
- ម្ចាស់គម្រោងត្រូវតែពិនិត្យផែនទីនេះឱ្យបានច្បាស់ មុនពេលប្រើប្រាស់
- មិនអាចកាត់បន្ថយទំហំផែនទីបាន ឬប្រើប្រាស់ផែនទីនេះសម្រាប់ការប្រកួតប្រជែង
- ក្នុងករណីមានការកែសម្រួល ឬការកែប្រែ ម្ចាស់គម្រោងត្រូវតែជូនដំណឹងដល់ម្ចាស់គម្រោង
- ក្នុងករណីមានការកែសម្រួល ឬការកែប្រែ ម្ចាស់គម្រោងត្រូវតែជូនដំណឹងដល់ម្ចាស់គម្រោង
- មិនអាចកាត់បន្ថយទំហំផែនទីបាន ឬប្រើប្រាស់ផែនទីនេះសម្រាប់ការប្រកួតប្រជែង
- ក្នុងករណីមានការកែសម្រួល ឬការកែប្រែ ម្ចាស់គម្រោងត្រូវតែជូនដំណឹងដល់ម្ចាស់គម្រោង

The Room Design Studio By Muraya.

WARNING

- This drawing shall not be used for construction unless certified.
- Contractor to verify all dimensions of existing works on site before commencing any work or preparing shop drawings.
- Do not scale drawings, use written dimensions only.
- All measurements in millimeters.
- All levels in meters.
- This drawing is to be read in conjunction with the specifications and conditions of contract.
- This drawing and design are copyright and no portion may be produced without the permission of The Room Design Studio By Muraya.

REVISIONS:

H		
G		
F		
E		
D		
C		
B		
A	Revision 1	2018.04.24

REF: កំណត់សម្គាល់/Remarks

Date

ឈ្មោះគម្រោង/Project Title:

UNDP

ឈ្មោះរូប/Drawing Title:

CEILING AND LIGHTING
SECOND FLOOR LAYOUT

ជំពូកគម្រោង/Phase:

គម្រោង/CONCEPT DESIGN

គម្រោង/DETAILED DESIGN

មុខតំណែង/POSITION	ឈ្មោះ/NAME
អគ្គនាយក/Director:	P.J
គ្រប់គ្រងគម្រោង/Project Manager:	P.J
ពិនិត្យ/Checked by:	P.J
គូររូប/Drawn by:	U.D
ចេញផ្សាយ/Issued for:	

ចេញផ្សាយ/Issued Date: 09 APRIL 2018	មាត្រដ្ឋាន/Scale: 1/100 (A3)
លេខគម្រោង/Drawing No: KHATP-0221_104C	