

DZ
architectural
design studio

DZOVAG MANDJIKIAN

UNDP YEREVAN OFFICES RC ROOM

Yerevan - Armenia

Drawings & Specifications

13th of September 2019

INDEX

D001 – Finishes

D002 – RC Room GA Plan

D003 – RC Room Demolition Plan

D004 – RC Room Demolition Floor Plan & Demolition Ceiling plan

D005 – RC Room Furniture Layout Plan

D006 – RC Room Reflected Ceiling plan

D007 – RC Room Electrical & HVAC Plan

D008 – RC Room Floor Finish Plan

D009 – RC Room Elevations

D010 – RC Room Elevations

D011 – RC Room Separating Glass Wall Option 2

WD001 – RC Room Typical Office Table

WD002 – RC Room Office Table

WD003 – RC Room Intern Table

WD004 – RC Room Coat Hanger

WD005 – RC Room Office Drawer & Wall Shelf

WD005 – RC Room Writing Board

V001 – RC Room Visual A

V002 – RC Room Visual B

FINISHES

PT 01

D0000 3YY 00033

T0000r00RAL 901 0 V0r000r00 000

PT 02

D000049 GG 02001

PT 03

D000031 BG 20004

FL 01

K000d0H0000r0V0000

WD 01

MDF 000000d W0000R009010

WD 02

E0000r H1140

MT 01

R007047

MT 02

R009000

GENERAL NOTES

ALL CONSTRUCTION AND FABRICATION SHALL COMPLY WITH THE CURRENT BUILDING CODES, ORDINANCES, STATUTES AND ALL OTHER APPLICABLE CODES WHICH GOVERN THE SITE FOR WHICH THESE DRAWINGS PERTAIN.

THE MILLWORK JOINTERY CONTRACTOR SHALL INVESTIGATE, VERIFY AND BE RESPONSIBLE FOR ALL CONDITIONS AND DIMENSIONS OF THE FIXTURES AND SHALL NOTIFY INTERNATIONAL DESIGN STUDIO ABOUT ANY CONDITION ARISING FROM THIS INVESTIGATION THAT REQUIRES MODIFICATION OR CHANGE BEFORE PROCEEDING WITH WORKS.

ALL DIMENSIONS ARE MEASURED TO GRID LINE, FACE OF MASONRY OR FACE FINISHED WALL UNLESS OTHERWISE NOTED. ALL WRITTEN DIMENSIONS SHALL HAVE PRECEDENCE OVER SCALING OF THE DRAWINGS. DRAWINGS SHOULD NOT BE SCALED. IF MORE DIMENSIONS ARE REQUIRED, NOTIFY INTERNATIONAL DESIGN STUDIO IMMEDIATELY. ALL DIMENSIONS SHALL BE VERIFIED ON SITE AND INTERNATIONAL DESIGN STUDIO SHALL BE NOTIFIED OF ANY ERRORS OR DIMENSIONS REQUIRING CORRECTION BEFORE PROCEEDING WITH WORKS.

THE GENERAL CONTRACTOR SHALL BE RESPONSIBLE FOR PROVIDING ALL NECESSARY BLOCKING, BACKING, FRAMING, HANGERS OR ANY OTHER SUPPORTS FOR ALL FIXTURE, EQUIPMENT, CABINETRY, FURNISHINGS AND ALL ITEMS WHICH REQUIRE THE SAME.

CUTOUT PATTERNS AND/OR TEMPLATES SHALL BE PROVIDED BY THE SPECIALIST SUBCONTRACTOR SUPPLIER TO THE MILLWORK JOINTERY CONTRACTOR AND OR GENERAL CONTRACTOR FOR ALL ITEMS WHICH REQUIRE COORDINATION OF EQUIPMENT INTO BUILT-IN FIXTURES.

IT IS THE INTENT OF THE DRAWINGS THAT ALL EXPOSED SURFACES RECEIVE FINISHES AS INDICATED ON THE DRAWINGS OR IN THE SPECIFICATIONS UNLESS NOTED OTHERWISE. ANY SURFACES NOT HAVING A SPECIFIC FINISH NOTED, NOR ARE NOTED TO REMAIN UNFINISHED, SHALL BE BROUGHT TO THE ATTENTION OF THE ARCHITECT DESIGNER AND FINISHED AS THE ARCHITECT DESIGNERS INSTRUCTIONS.

FOR BUILDING CODES & FIRE STRATEGY REQUIREMENTS REFER TO THE ARCHITECT DRAWINGS THE CONTRACTOR IS TO VERIFY DOORS DETAILS AGAINST THE APPROVED FIRE STRATEGY.

ALL SAMPLES ARE TO BE APPROVED BY THE DESIGNER BEFORE MANUFACTURING.

ELECTRICAL, WITH TELEPHONE, AUDIO VISUAL SYSTEM & A/C DRAWING ARE PREPARED SEPARATING BY THE M.E.P CONSULTANT.

THESE DRAWINGS ARE FOR DESIGN INTENT ONLY, NOT TO BE USED FOR CONSTRUCTION. CONTRACTOR TO PROVIDE THEIR SHOP DRAWINGS FOR APPROVAL.

KEY PLAN



GENERAL NOTES

- DO NOT SCALE FROM THIS DRAWING.
- THIS DRAWING MUST BE READ IN CONJUNCTION WITH ALL OTHER RELEVANT DRAWINGS.
- CONTRACTOR MUST REPORT ANY DISCREPANCIES PRIOR TO EXECUTION OF ANY WORKS.
- ALL DIMENSIONS MUST BE VERIFIED ON SITE PRIOR TO ORDER OR MANUFACTURE OF MATERIALS OR PRODUCTION OF SHOP DRAWINGS.

REV	DATE	DESCRIPTION	REVISED BY
ISSUE: FINAL DESIGN			
DESIGN & SUPERVISION CONSULTANT			


DESIGN BUILDER

SUB CONTRACTOR


PROJECT
UNDP YEREVAN OFFICES

SHEET TITLE
RC ROOM FINISHES
UNDPYO_01907_D001

APPROVALS		
ISSUED BY:	INITIALS	DATE
CHECKED BY:		
INTEGRATED CHECKED BY:		
SCALE	PROJECT NO. 01907	

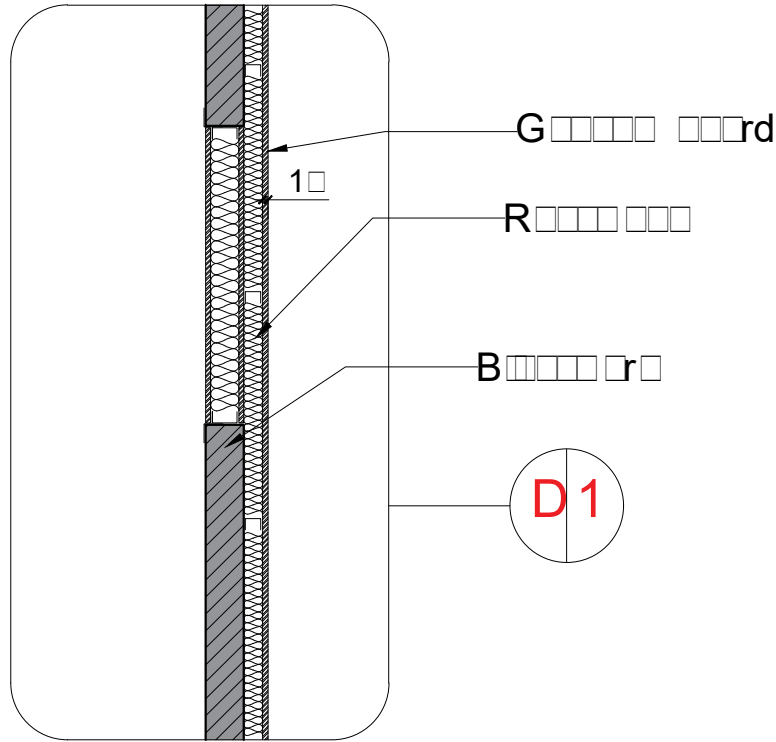

4 D 1
UNDP Y O
SCALE 1:20

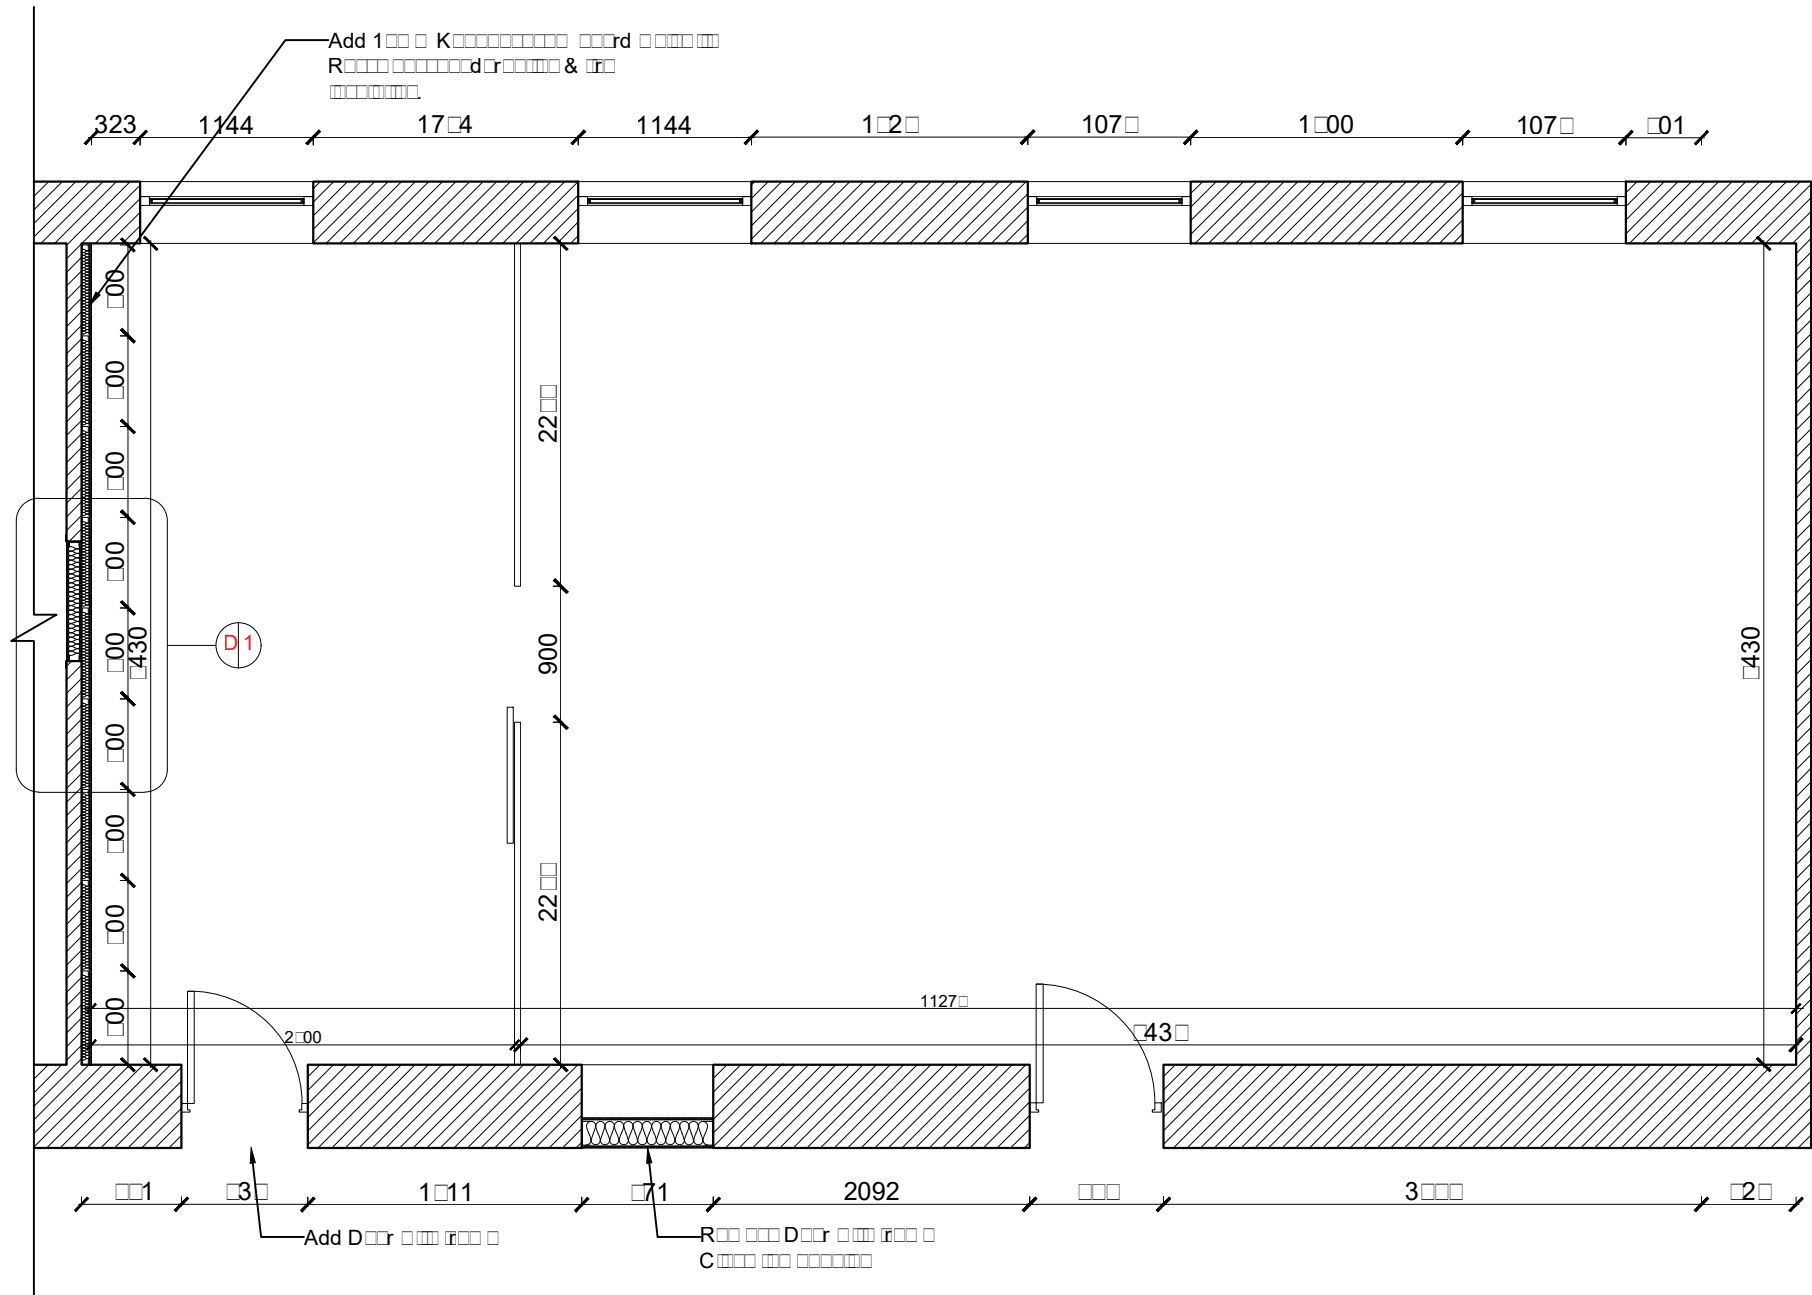

1 GA PL
UN RC OFFICE YEREVAN
SCALE 1:0

KEY PLAN



GENERAL NOTES

- DO NOT SCALE FROM THIS DRAWING.
- THIS DRAWING MUST BE READ IN CONJUNCTION WITH ALL OTHER RELEVANT DRAWINGS.
- CONTRACTOR MUST REPORT ANY DISCREPANCIES PRIOR TO EXECUTION OF ANY WORKS.
- ALL DIMENSIONS MUST BE VERIFIED ON SITE PRIOR TO ORDER OR MANUFACTURE OF MATERIALS OR PRODUCTION OF SHOP DRAWINGS.

REV	DATE	DESCRIPTION	REVISED BY
ISSUE:		FINAL DESIGN	

DESIGN & SUPERVISION CONSULTANT

DESIGN BUILDER

SUB CONTRACTOR

PROJECT

UNDP RC YEREVAN
OFFICES

SHEET TITLE


UN RC ROOM GA PLAN

UNDPYO_01907_D002

APPROVALS

ISSUED BY:	INITIALS	DATE
CHECKED BY:		
INTEGRATED CHECKED BY:		
SCALE		

PROJECT NO.
01907

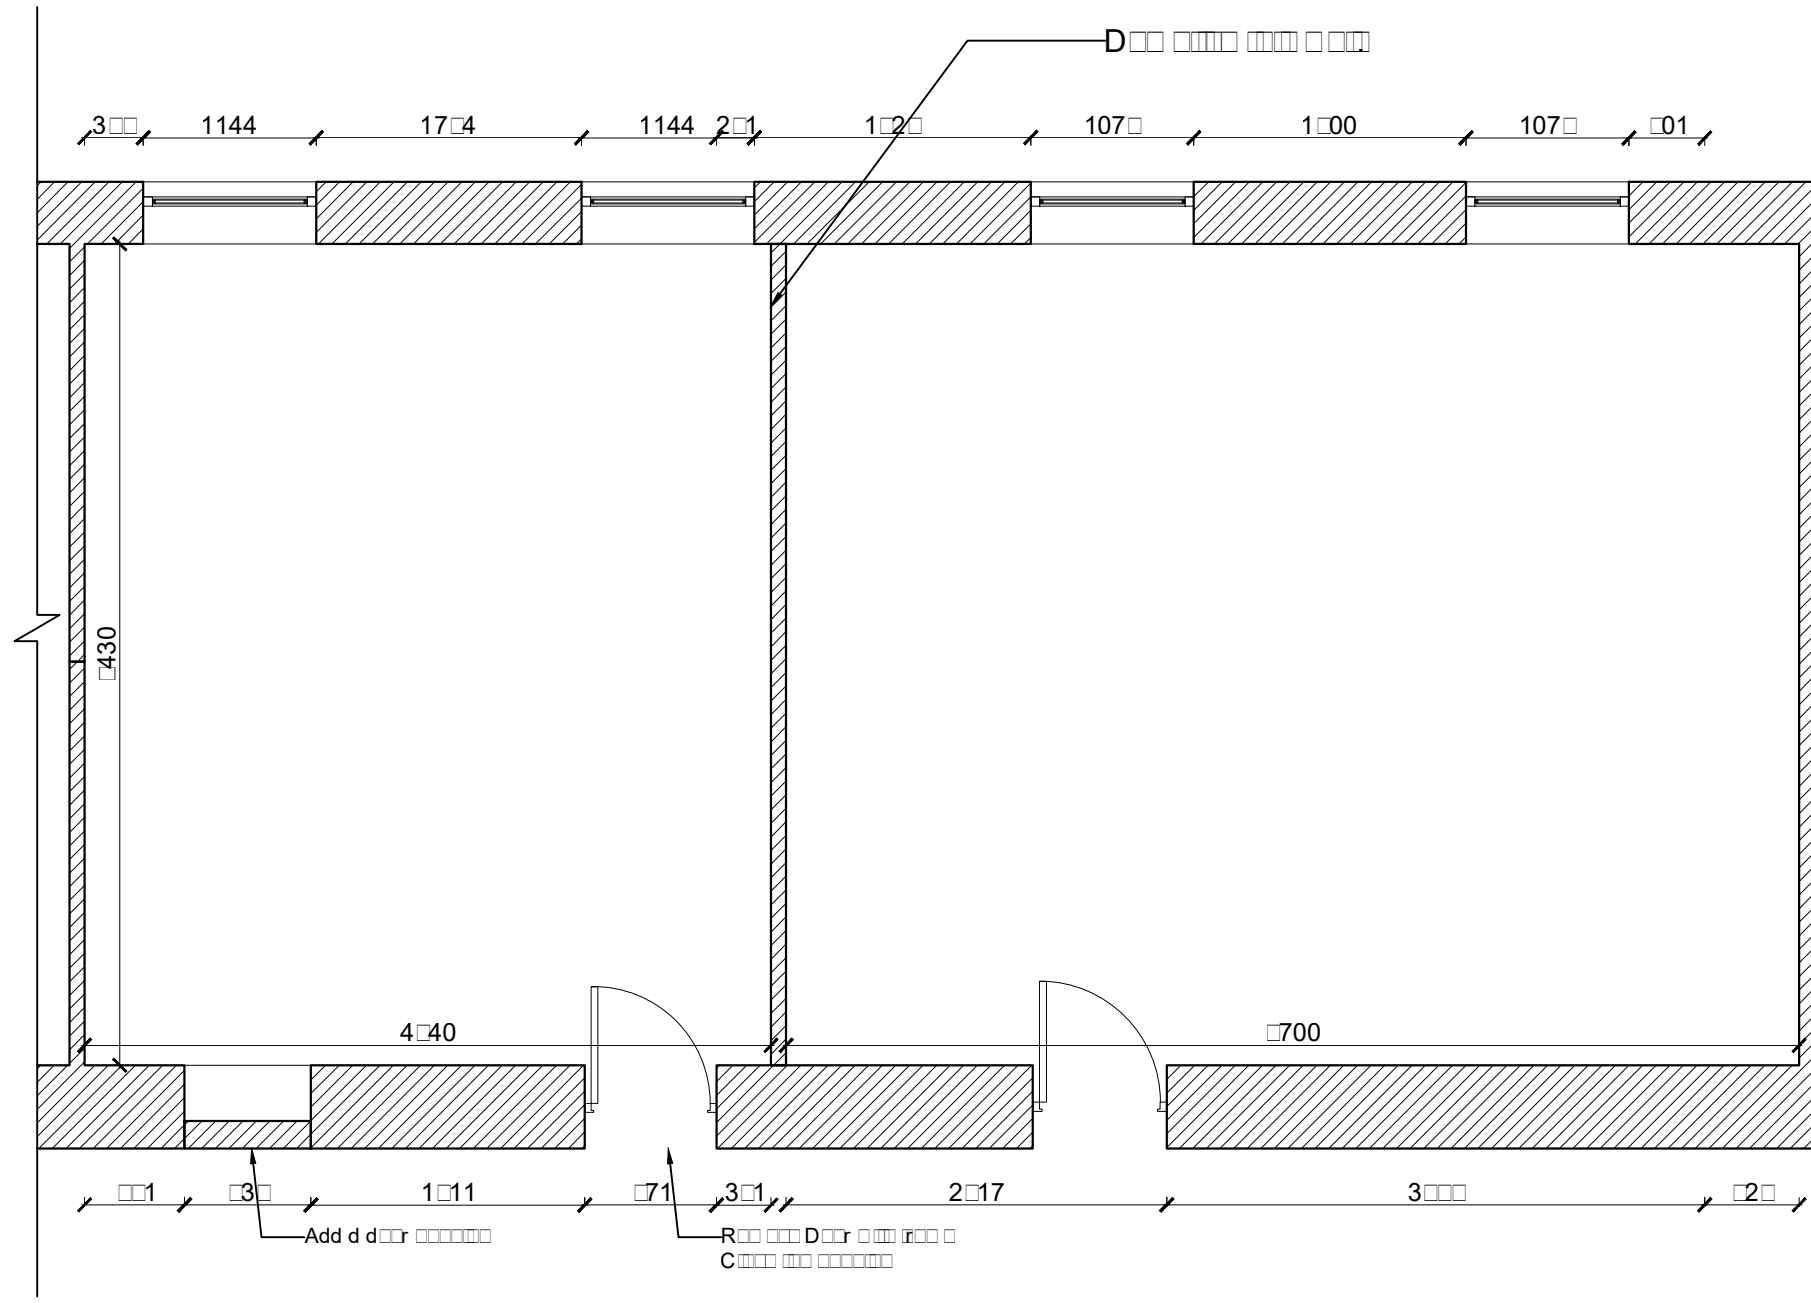

1 D P
UN RC OFFICE YEREVAN SCALE 1:0

KEY PLAN

GENERAL NOTES

1. DO NOT SCALE FROM THIS DRAWING.

2. THIS DRAWING MUST BE READ IN CONJUNCTION WITH ALL OTHER RELEVANT DRAWINGS.

3. CONTRACTOR MUST REPORT ANY DISCREPANCIES PRIOR TO EXECUTION OF ANY WORKS.

4. ALL DIMENSIONS MUST BE VERIFIED ON SITE PRIOR TO ORDER OR MANUFACTURE OF MATERIALS OR PRODUCTION OF SHOP DRAWINGS.

REV	DATE	DESCRIPTION	REVISED BY
ISSUE:		FINAL DESIGN	
DESIGN & SUPERVISION CONSULTANT			

DESIGN BUILDER

SUB CONTRACTOR

PROJECT

UNDP RC YEREVAN OFFICES

SHEET TITLE

UN RC ROOM DEMOLITION PLAN

UNDPYO_01907_D003

APPROVALS

ISSUED BY:	INITIALS	DATE
CHECKED BY:		
INTEGRATED CHECKED BY:		

SCALE

PROJECT NO.

01907



GENERAL NOTES

- 1. DO NOT SCALE FROM THIS DRAWING.
- 2. THIS DRAWING MUST BE READ IN CONJUNCTION WITH ALL OTHER RELEVANT DRAWINGS.
- 3. CONTRACTOR MUST REPORT ANY DISCREPANCIES PRIOR TO EXECUTION OF ANY WORKS.
- 4. ALL DIMENSIONS MUST BE VERIFIED ON SITE PRIOR TO ORDER OR MANUFACTURE OF MATERIALS OR PRODUCTION OF SHOP DRAWINGS.

REV	DATE	DESCRIPTION	REVISED BY
ISSUE: FINAL DESIGN			
DESIGN & SUPERVISION CONSULTANT			

DESIGN BUILDER

SUB CONTRACTOR


PROJECT

UNDP RC YEREVAN
OFFICES


SHEET TITLE

UN RC ROOM DEMOLITION
FLOOR PLAN &
DEMOLITION CEILING PLAN
UNDPYO_01907_D004


APPROVALS		
ISSUED BY:	INITIALS	DATE
CHECKED BY:		
INTEGRATED CHECKED BY:		
SCALE	PROJECT NO. 01907	

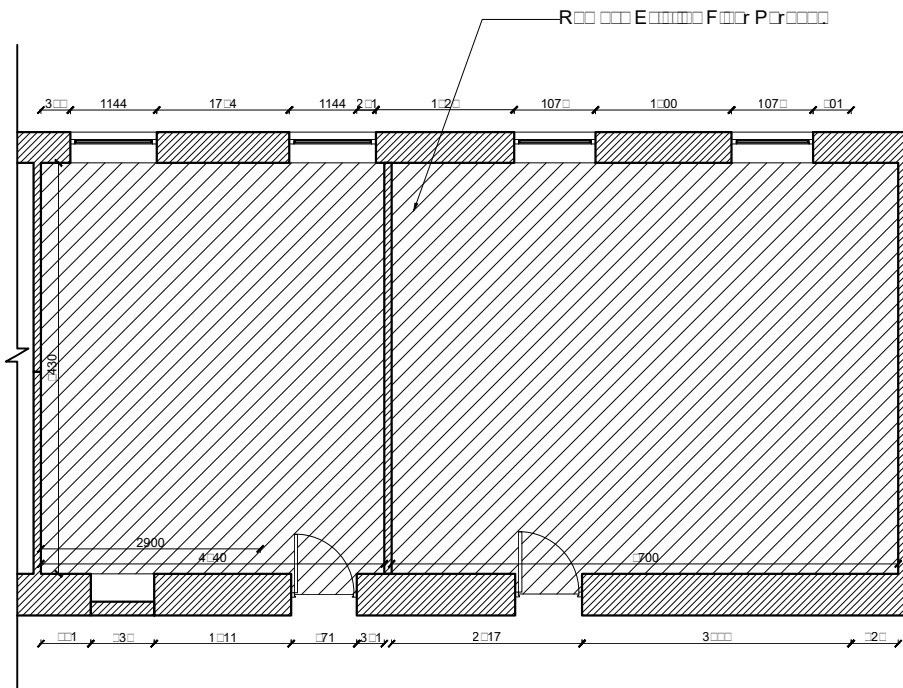


1 D00 E0000 F000 P000
UN RC OFFICE YEREVAN SCALE 1:100

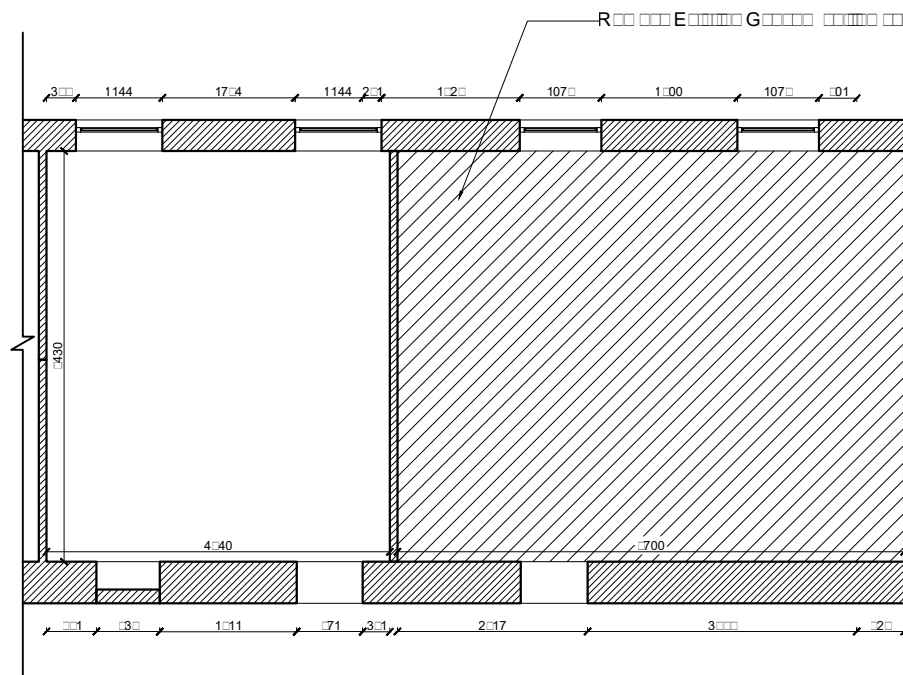

1 D00 E0000 C0000 P000
UN RC OFFICE YEREVAN SCALE 1:100

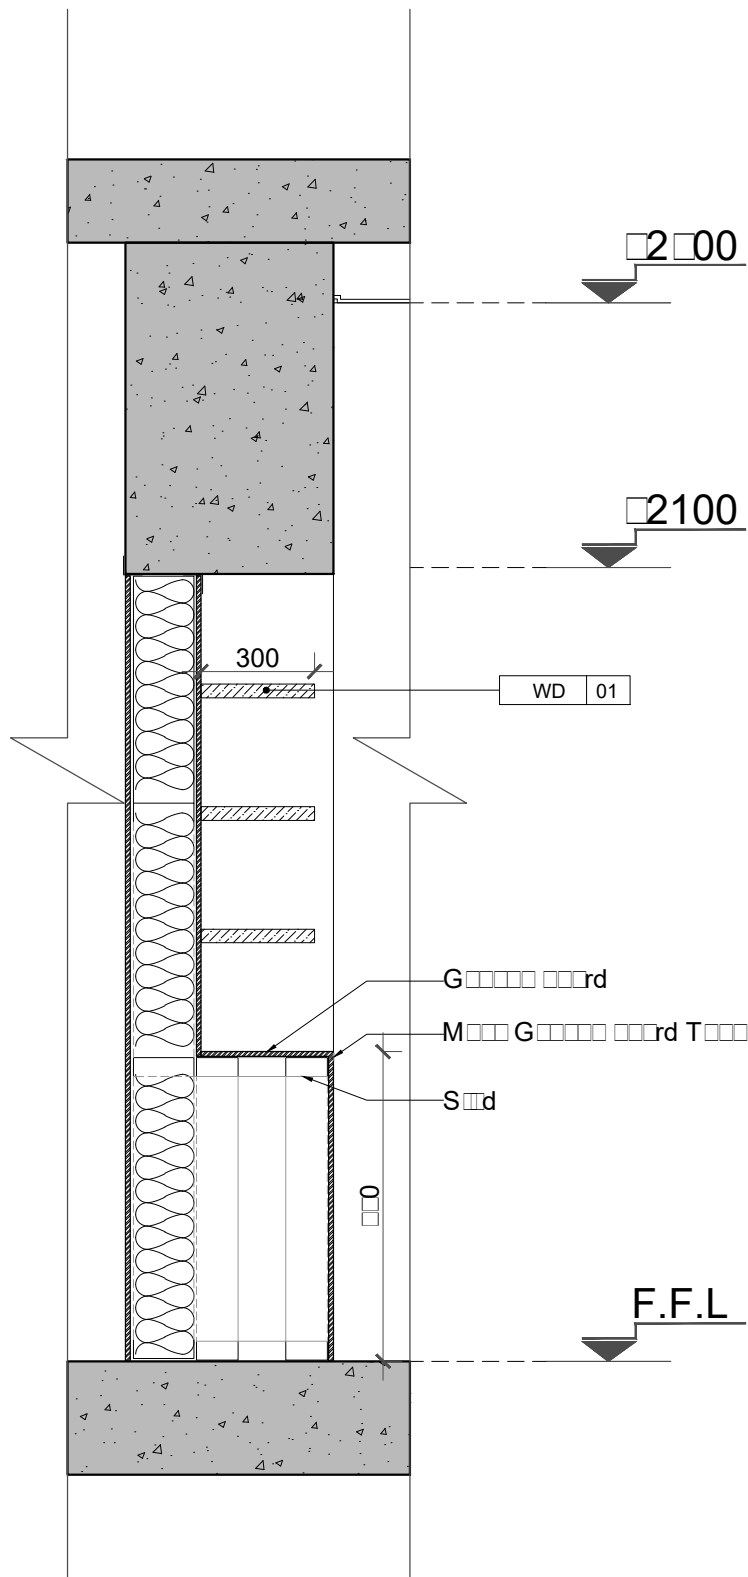

3 S AA
UNDP Y O
SCALE 1:20

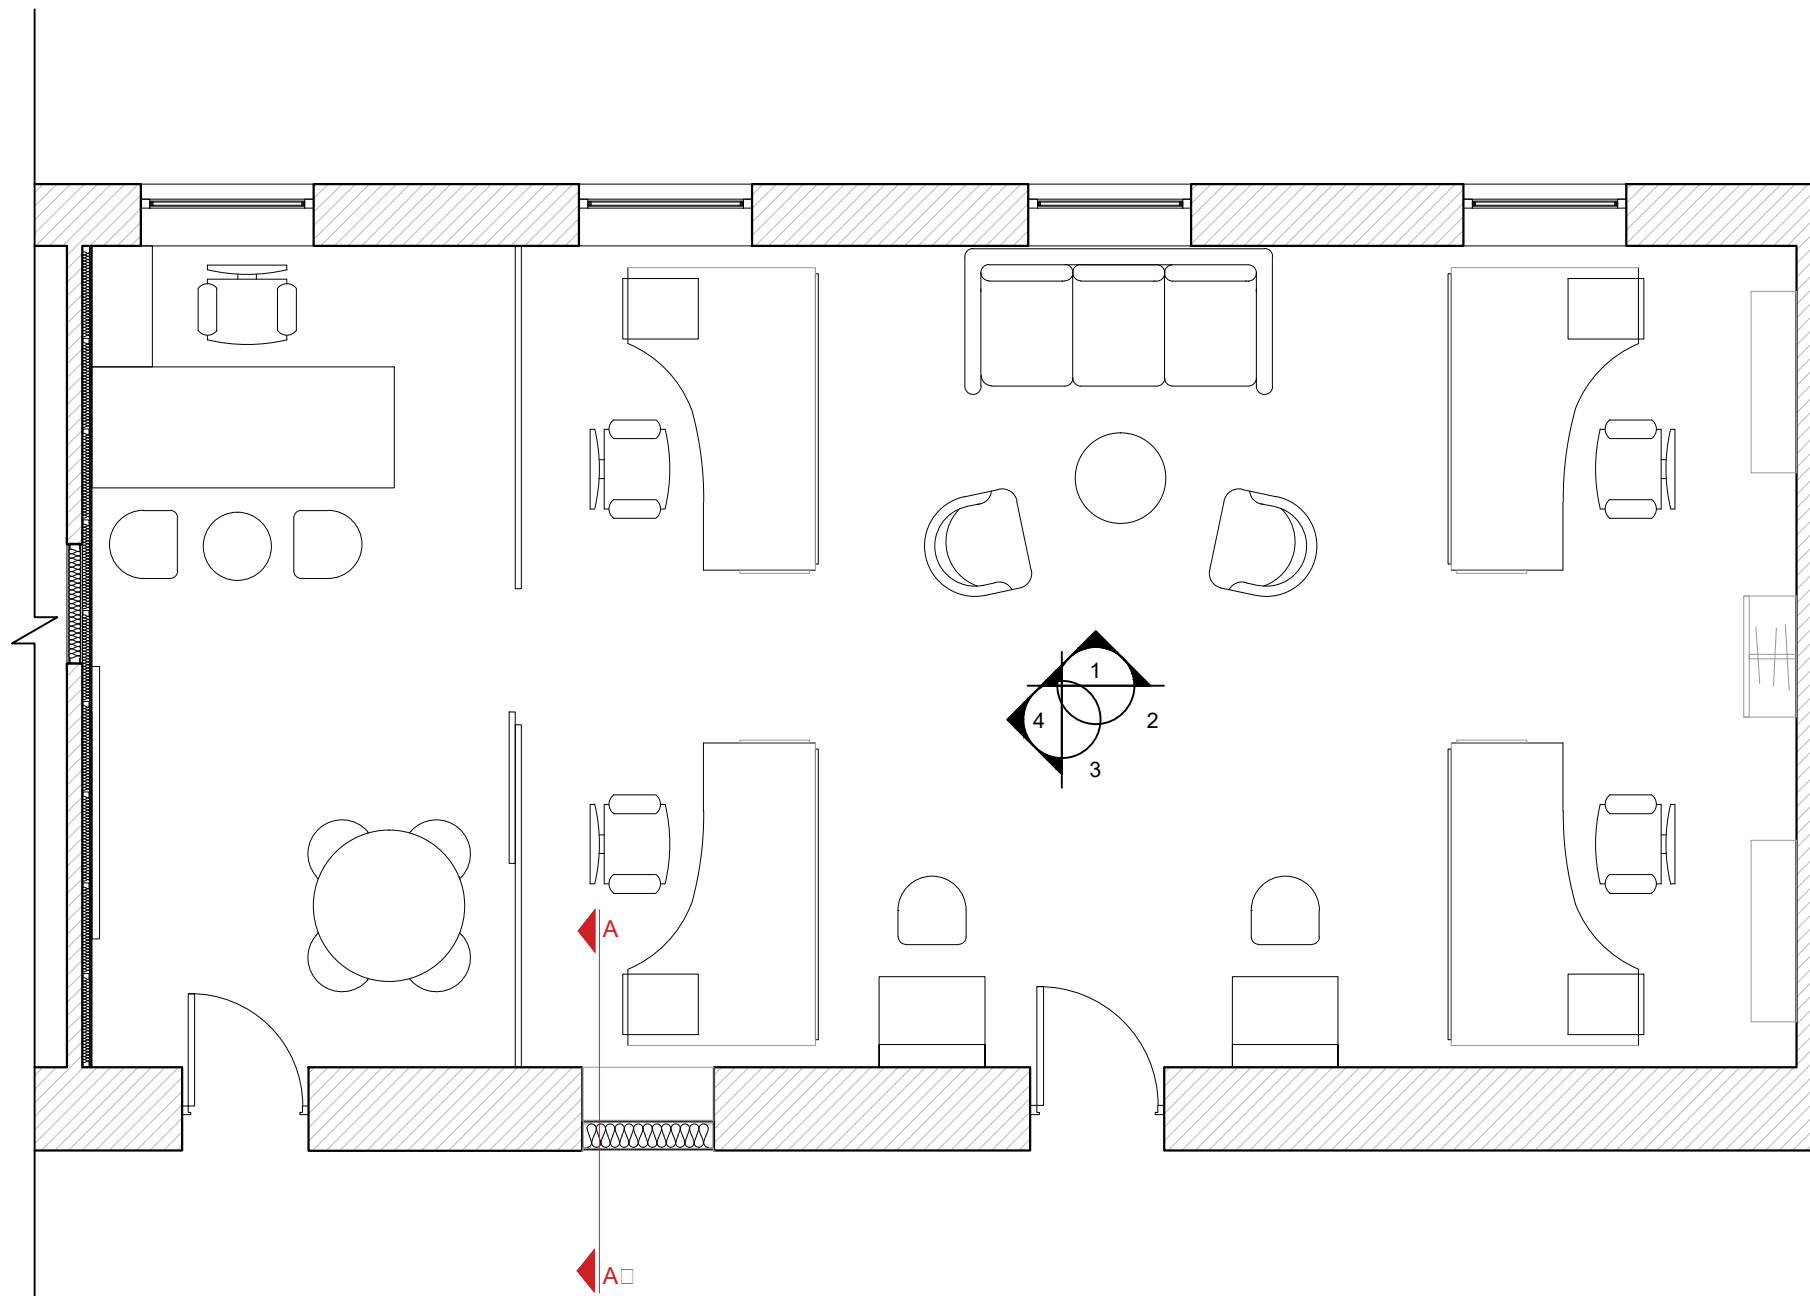

1 Furniture Layout Plan
UN RC OFFICE YEREVAN
SCALE 1:50

KEY PLAN



GENERAL NOTES

1. DO NOT SCALE FROM THIS DRAWING.
2. THIS DRAWING MUST BE READ IN CONJUNCTION WITH ALL OTHER RELEVANT DRAWINGS.
3. CONTRACTOR MUST REPORT ANY DISCREPANCIES PRIOR TO EXECUTION OF ANY WORKS.
4. ALL DIMENSIONS MUST BE VERIFIED ON SITE PRIOR TO ORDER OR MANUFACTURE OF MATERIALS OR PRODUCTION OF SHOP DRAWINGS.

REV	DATE	DESCRIPTION	REVISED BY
ISSUE:		FINAL DESIGN	

DESIGN & SUPERVISION CONSULTANT

DESIGN BUILDER

SUB CONTRACTOR

PROJECT


UNDP RC YEREVAN
OFFICES

SHEET TITLE

UN RC ROOM FURNITURE
LAYOUT PLAN

UNDPYO_01907_D00

APPROVALS		
ISSUED BY:	INITIALS	DATE
CHECKED BY:		
INTEGRATED CHECKED BY:		
SCALE	PROJECT NO. 01907	

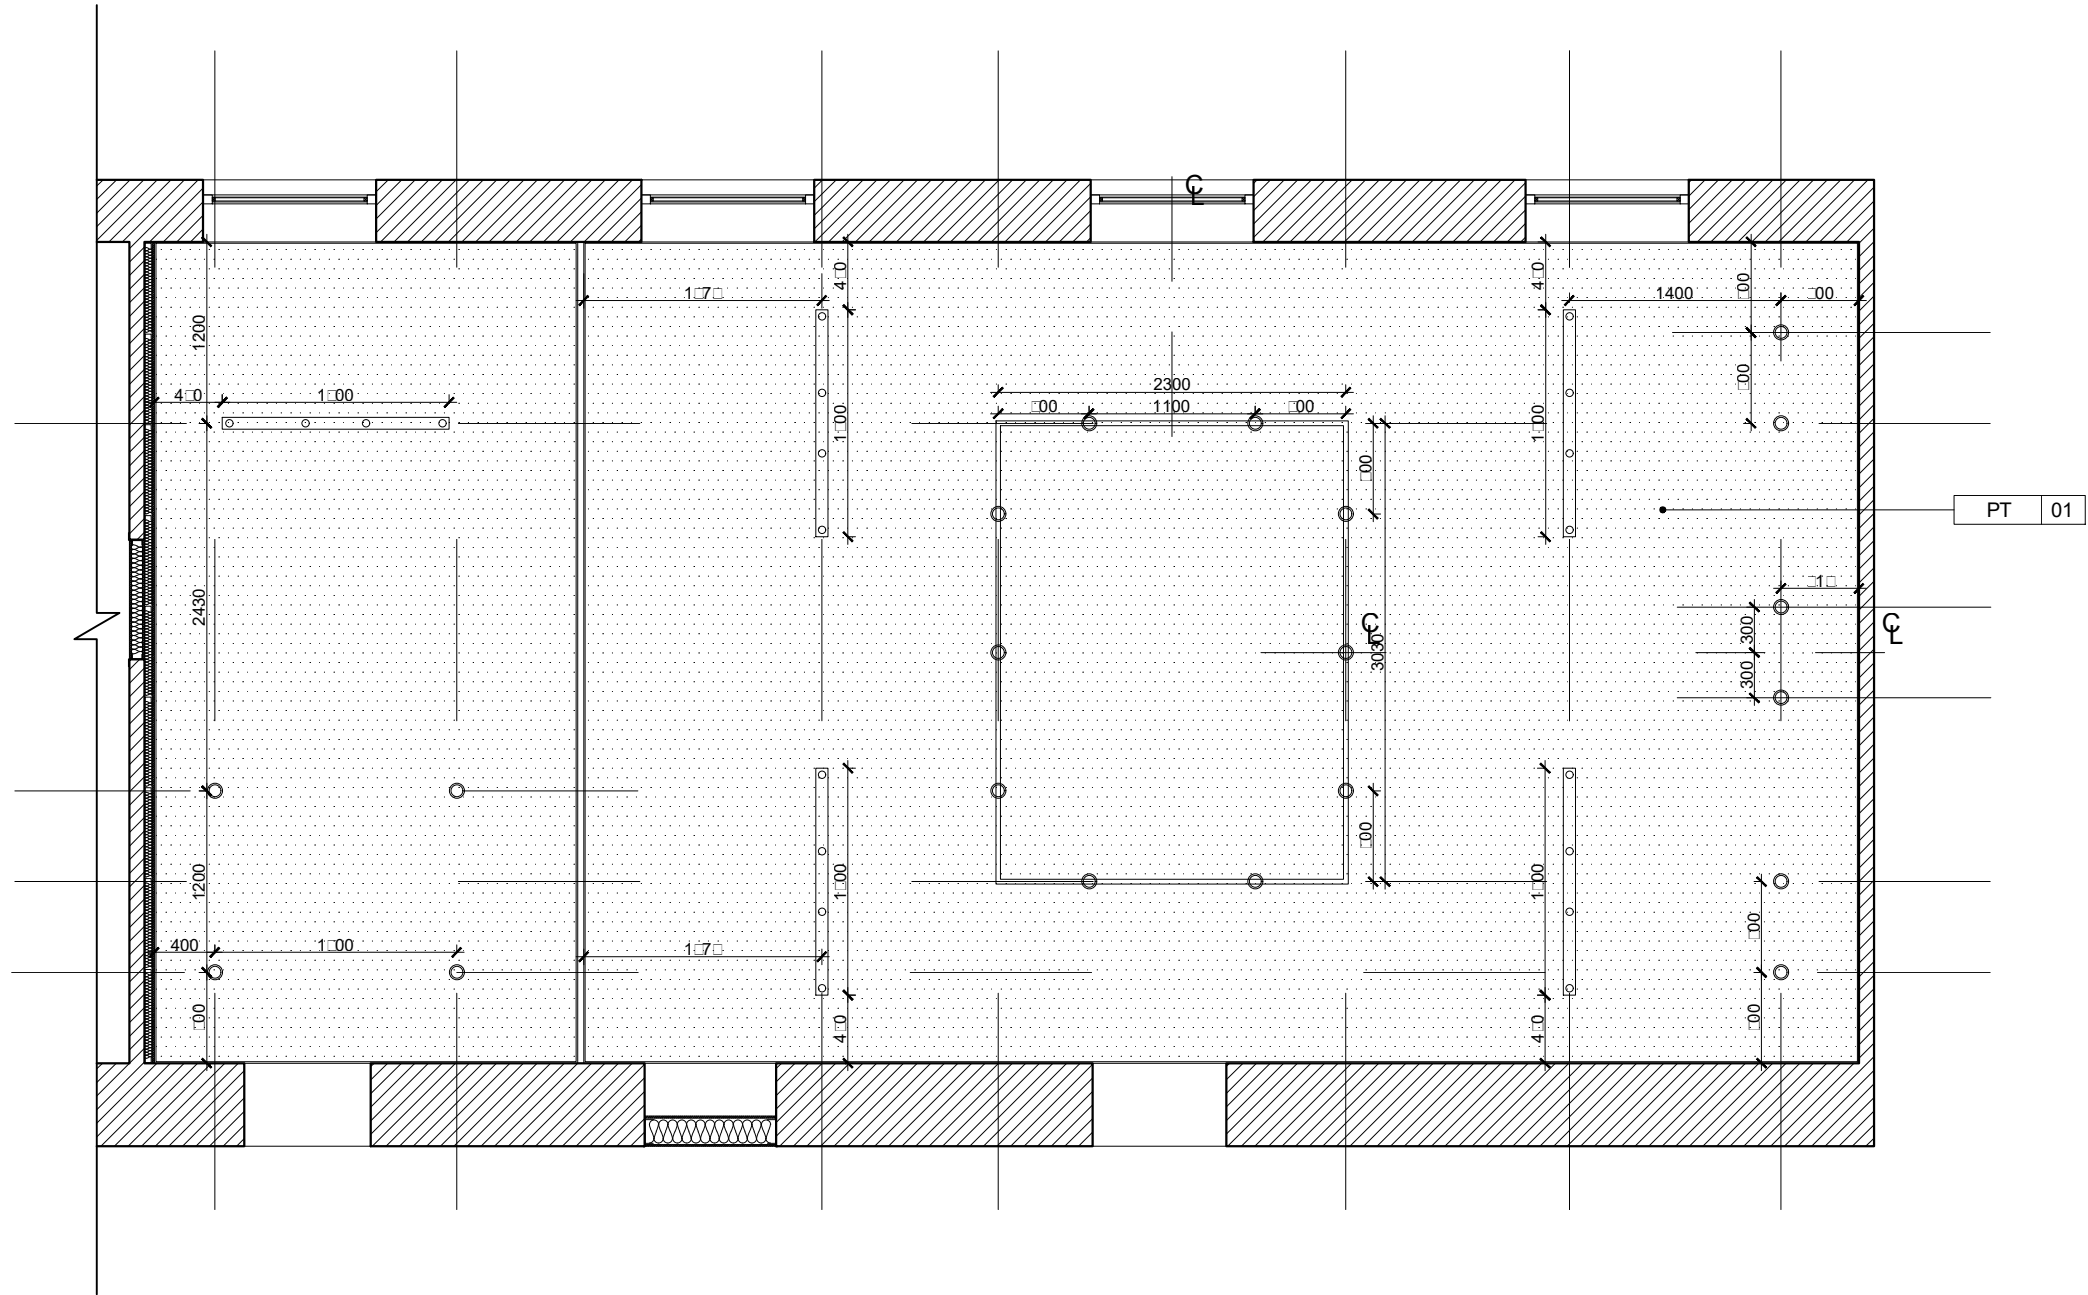

1 R d C P
UN RC OFFICE YEREVAN SCALE 1:10

KEY PLAN



GENERAL NOTES

- DO NOT SCALE FROM THIS DRAWING.
- THIS DRAWING MUST BE READ IN CONJUNCTION WITH ALL OTHER RELEVANT DRAWINGS.
- CONTRACTOR MUST REPORT ANY DISCREPANCIES PRIOR TO EXECUTION OF ANY WORKS.
- ALL DIMENSIONS MUST BE VERIFIED ON SITE PRIOR TO ORDER OR MANUFACTURE OF MATERIALS OR PRODUCTION OF SHOP DRAWINGS.

REV	DATE	DESCRIPTION	REVISED BY
ISSUE:		FINAL DESIGN	

DESIGN & SUPERVISION CONSULTANT

DESIGN BUILDER

SUB CONTRACTOR

PROJECT


UNDP RC YEREVAN
OFFICES

SHEET TITLE

UN RC ROOM REFLECTED
CEILING PLAN

UNDPYO_01907_D00

APPROVALS		
ISSUED BY:	INITIALS	DATE
CHECKED BY:		
INTEGRATED CHECKED BY:		
SCALE	PROJECT NO. 01907	

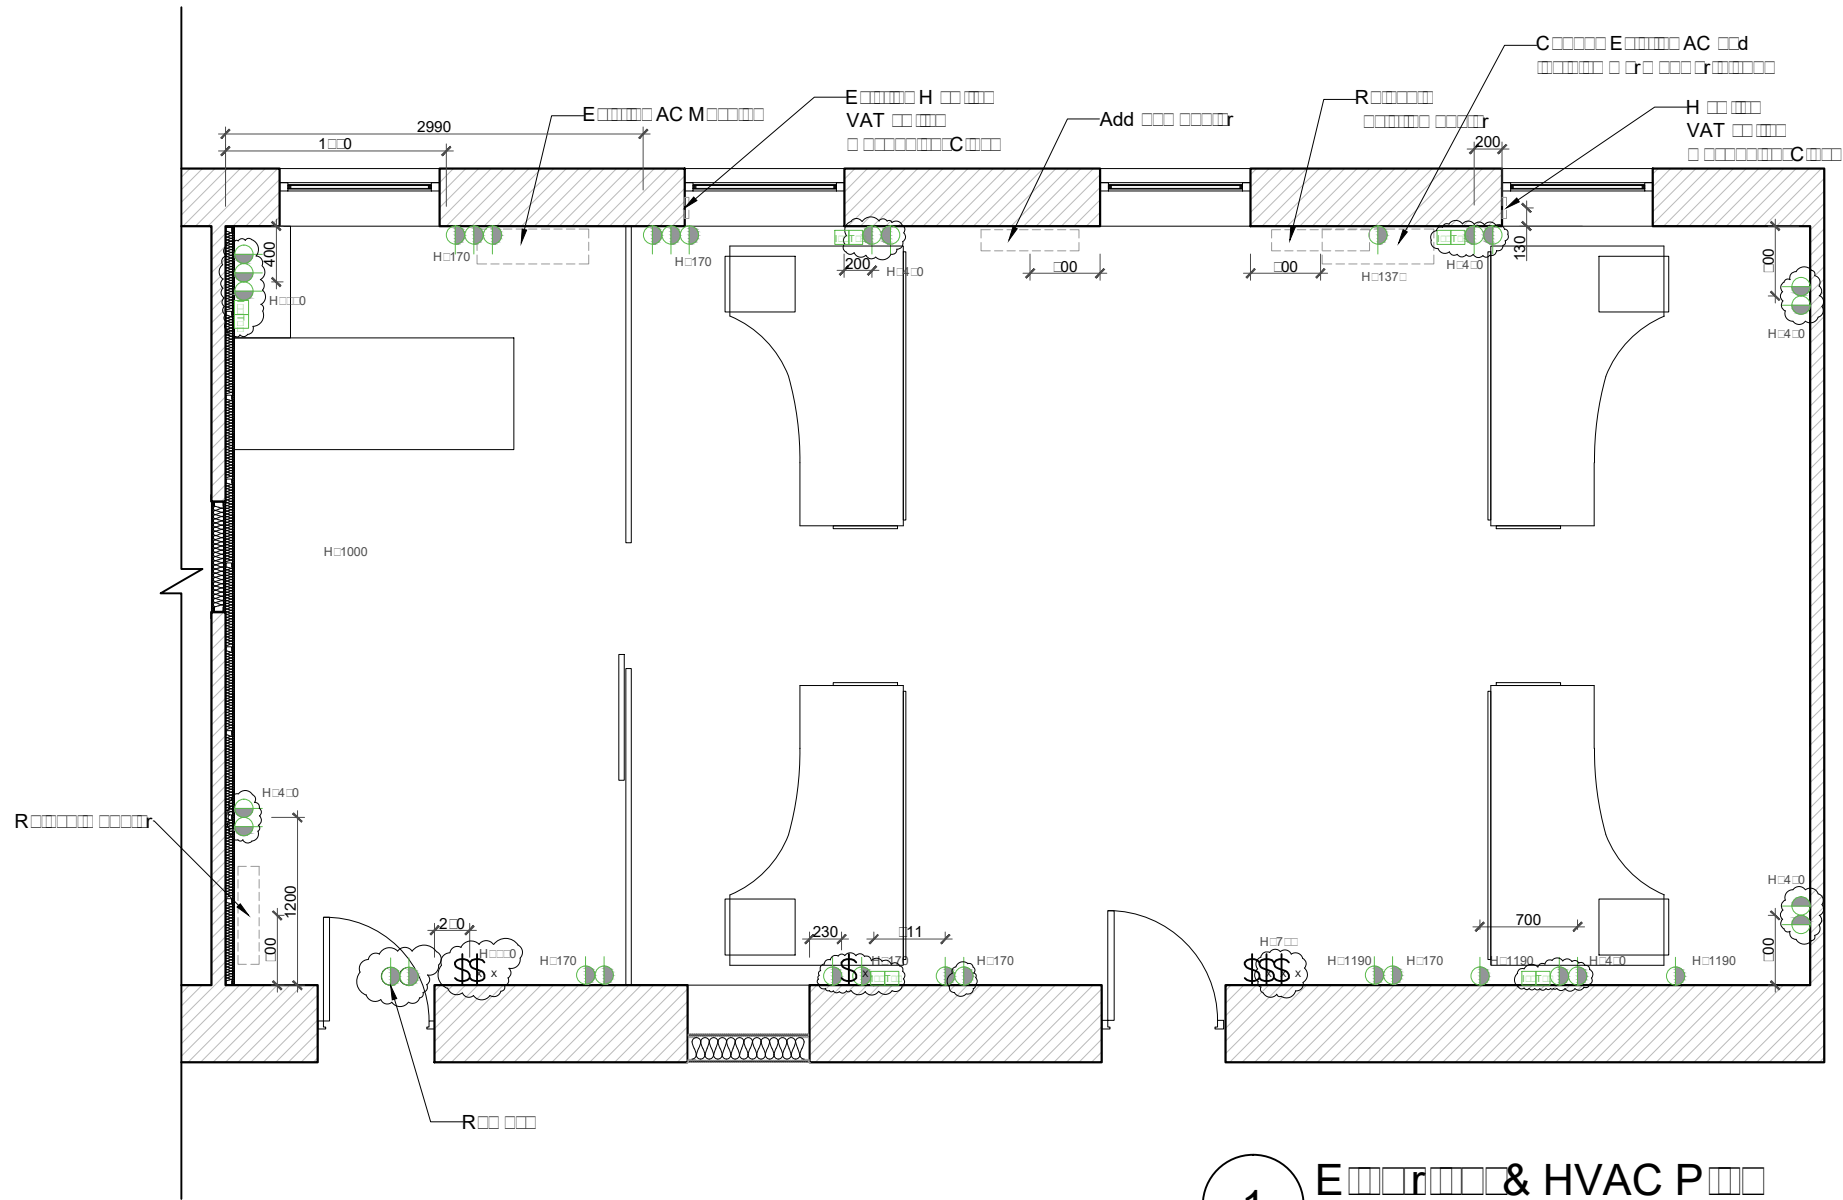

1 Electrical & HVAC Plan
UN RC OFFICE YEREVAN SCALE 1:100

KEY PLAN



GENERAL NOTES

- DO NOT SCALE FROM THIS DRAWING.
- THIS DRAWING MUST BE READ IN CONJUNCTION WITH ALL OTHER RELEVANT DRAWINGS.
- CONTRACTOR MUST REPORT ANY DISCREPANCIES PRIOR TO EXECUTION OF ANY WORKS.
- ALL DIMENSIONS MUST BE VERIFIED ON SITE PRIOR TO ORDER OR MANUFACTURE OF MATERIALS OR PRODUCTION OF SHOP DRAWINGS.

REV	DATE	DESCRIPTION	REVISED BY
ISSUE:		FINAL DESIGN	

DESIGN & SUPERVISION CONSULTANT

DESIGN BUILDER

SUB CONTRACTOR

PROJECT

UNDP RC YEREVAN OFFICES


SHEET TITLE

UN RC ROOM ELECTRICAL & HVAC PLAN


UNDPYO_01907_D007

APPROVALS

ISSUED BY:	INITIALS	DATE
CHECKED BY:		
INTEGRATED CHECKED BY:		
SCALE		PROJECT NO. 01907

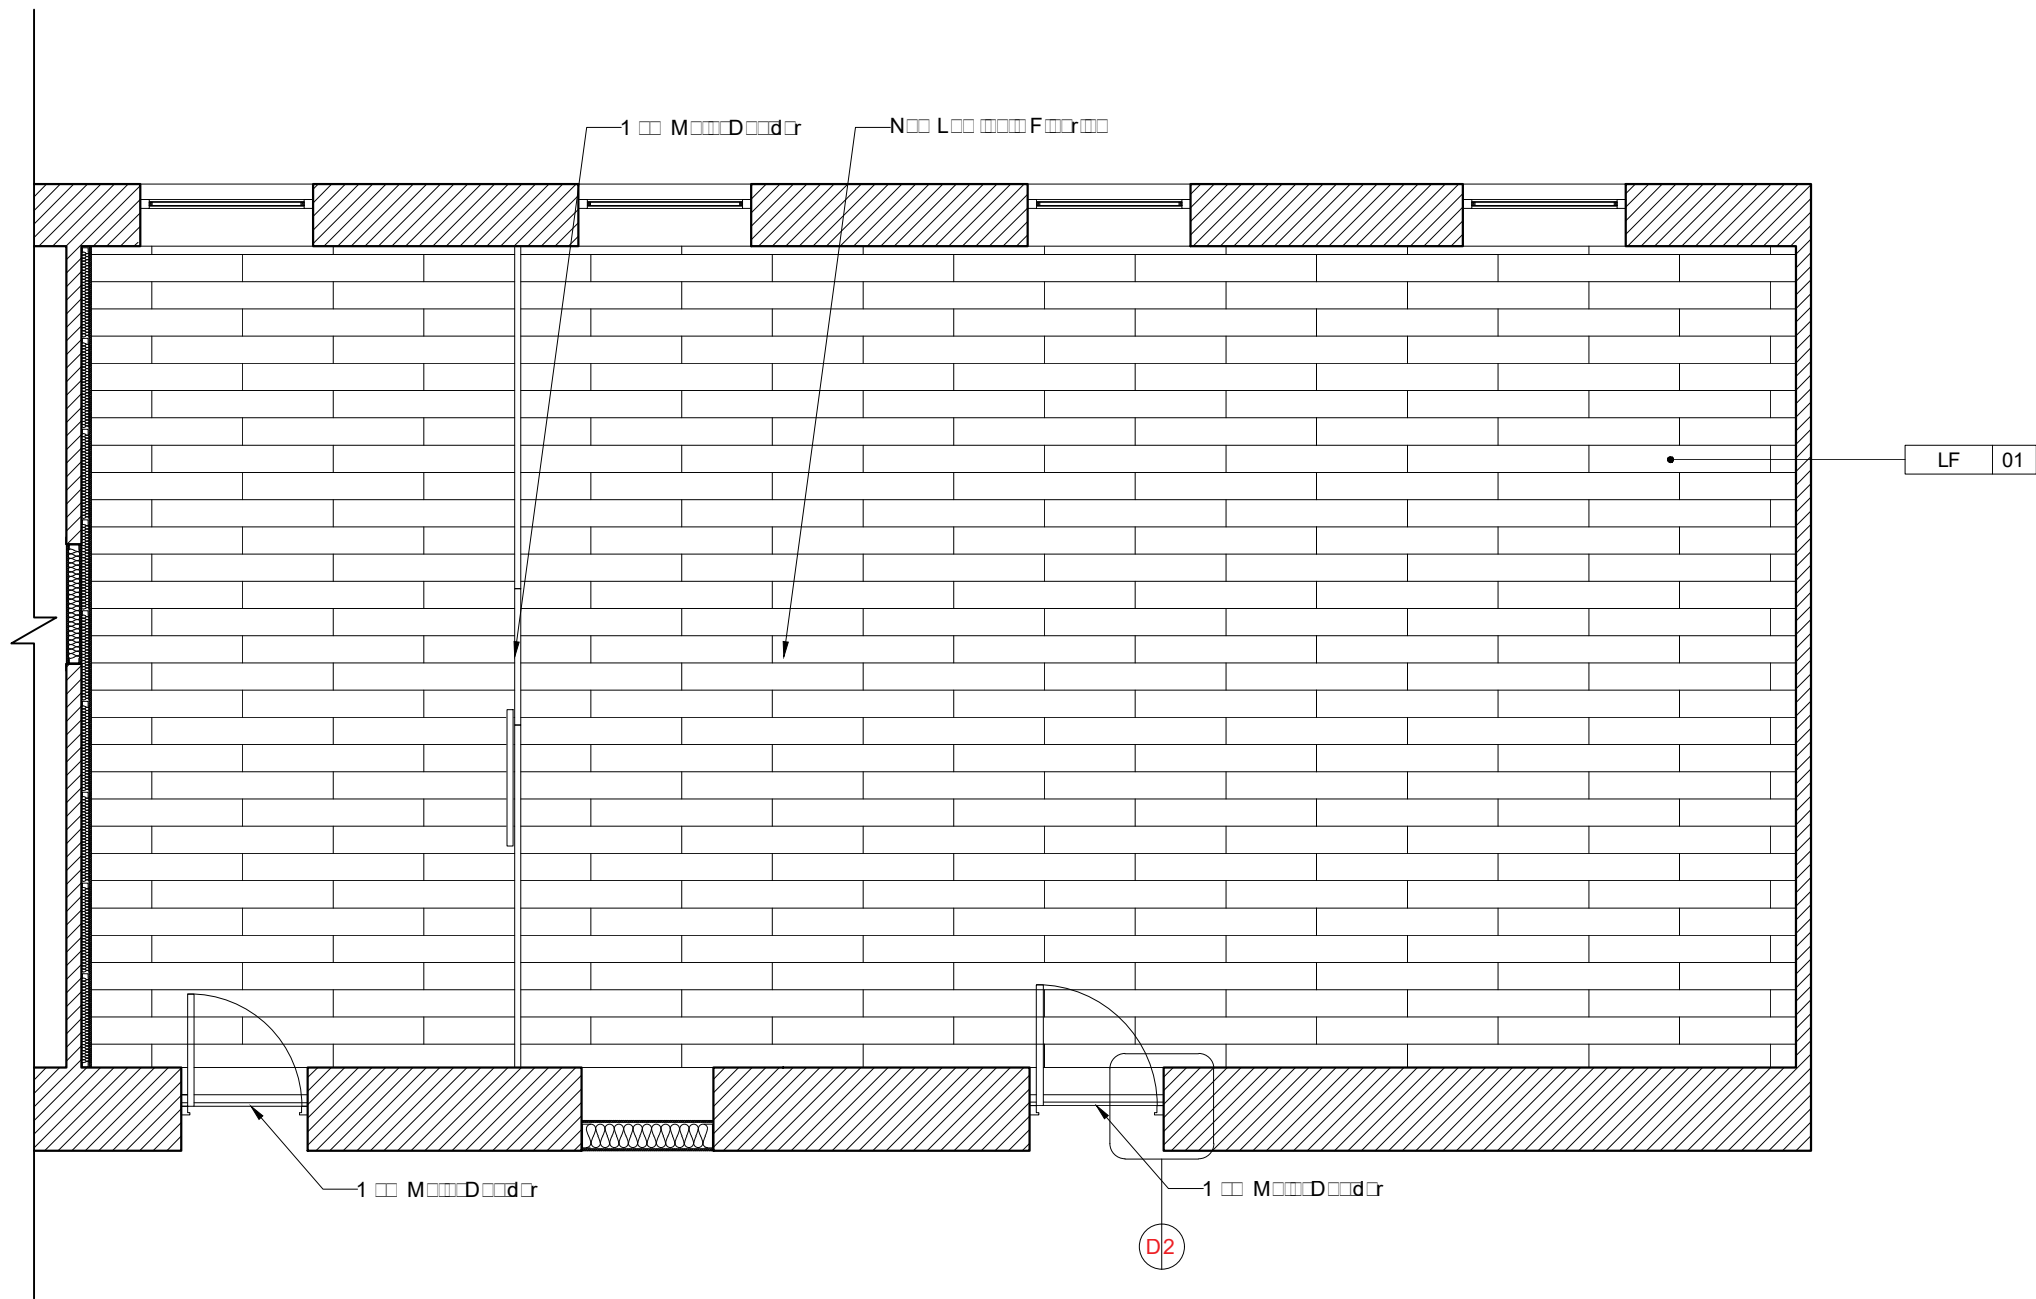

1 F F P
UN RC OFFICE YEREVAN SCALE 1:10

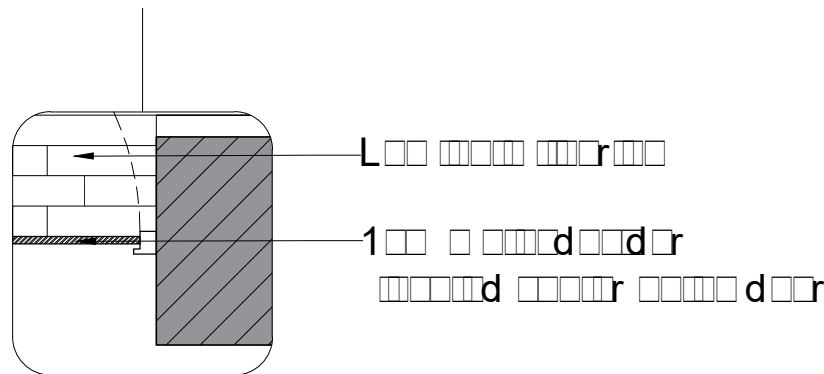

4 D2
UNDP Y O SCALE 1:20

KEY PLAN



GENERAL NOTES

- DO NOT SCALE FROM THIS DRAWING.
- THIS DRAWING MUST BE READ IN CONJUNCTION WITH ALL OTHER RELEVANT DRAWINGS.
- CONTRACTOR MUST REPORT ANY DISCREPANCIES PRIOR TO EXECUTION OF ANY WORKS.
- ALL DIMENSIONS MUST BE VERIFIED ON SITE PRIOR TO ORDER OR MANUFACTURE OF MATERIALS OR PRODUCTION OF SHOP DRAWINGS.

REV	DATE	DESCRIPTION	REVISED BY
ISSUE:		FINAL DESIGN	

DESIGN & SUPERVISION CONSULTANT

DESIGN BUILDER

SUB CONTRACTOR

PROJECT

UNDP RC YEREVAN
OFFICES

SHEET TITLE

UN RC ROOM FLOOR FINISH
PLAN

UNDPYO_01907_D00


APPROVALS

ISSUED BY:	INITIALS	DATE
CHECKED BY:		
INTEGRATED CHECKED BY:		


SCALE

PROJECT NO.

01907

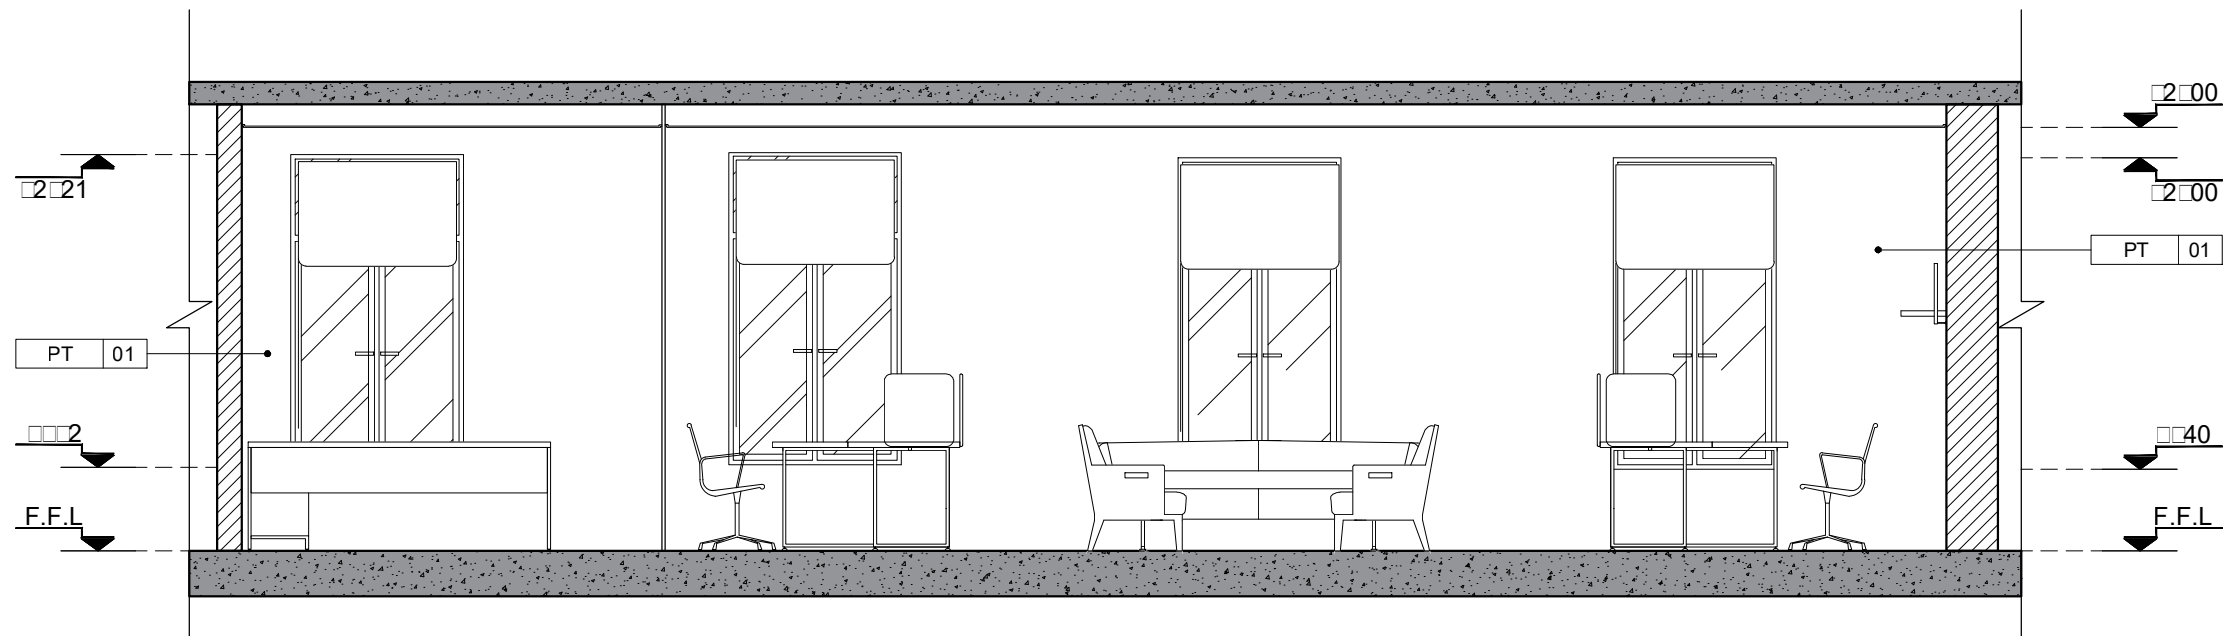

2 E 1 UN RC OFFICE YEREVAN SCALE 1:0

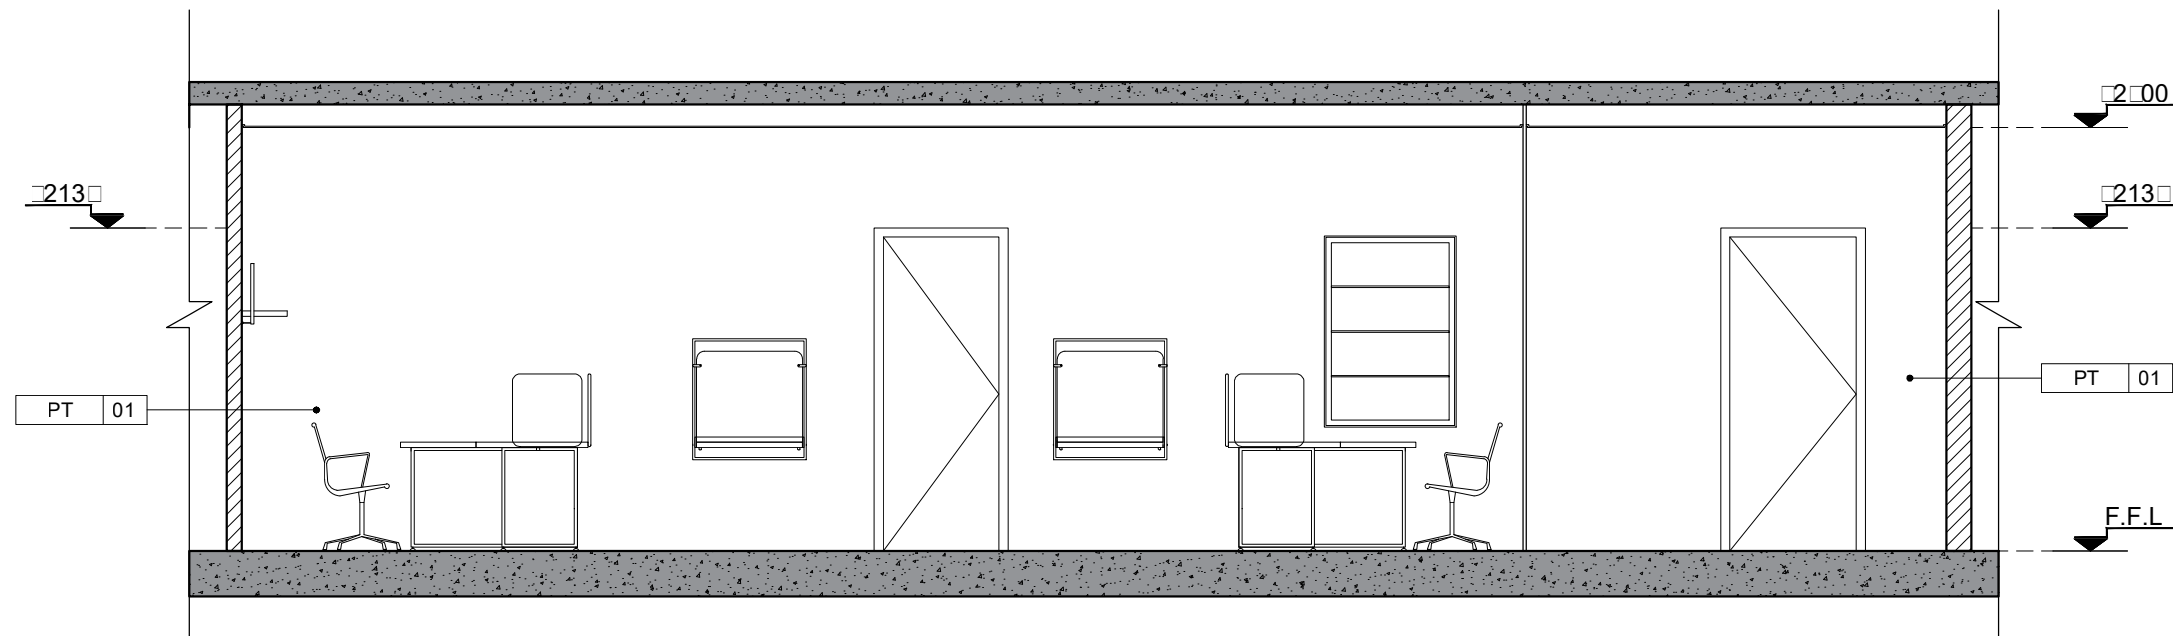

2 E 3 UN RC OFFICE YEREVAN SCALE 1:0

KEY PLAN



GENERAL NOTES

- DO NOT SCALE FROM THIS DRAWING.
- THIS DRAWING MUST BE READ IN CONJUNCTION WITH ALL OTHER RELEVANT DRAWINGS.
- CONTRACTOR MUST REPORT ANY DISCREPANCIES PRIOR TO EXECUTION OF ANY WORKS.
- ALL DIMENSIONS MUST BE VERIFIED ON SITE PRIOR TO ORDER OR MANUFACTURE OF MATERIALS OR PRODUCTION OF SHOP DRAWINGS.

REV	DATE	DESCRIPTION	REVISED BY
ISSUE: FINAL DESIGN			
DESIGN & SUPERVISION CONSULTANT			


DESIGN BUILDER

SUB CONTRACTOR


PROJECT
UNDP RC YEREVAN
OFFICES

SHEET TITLE
UN RC ROOM ELEVATIONS
UNDPYO_01907_D009


APPROVALS		
ISSUED BY:	INITIALS	DATE
CHECKED BY:		
INTEGRATED CHECKED BY:		
SCALE	PROJECT NO. 01907	

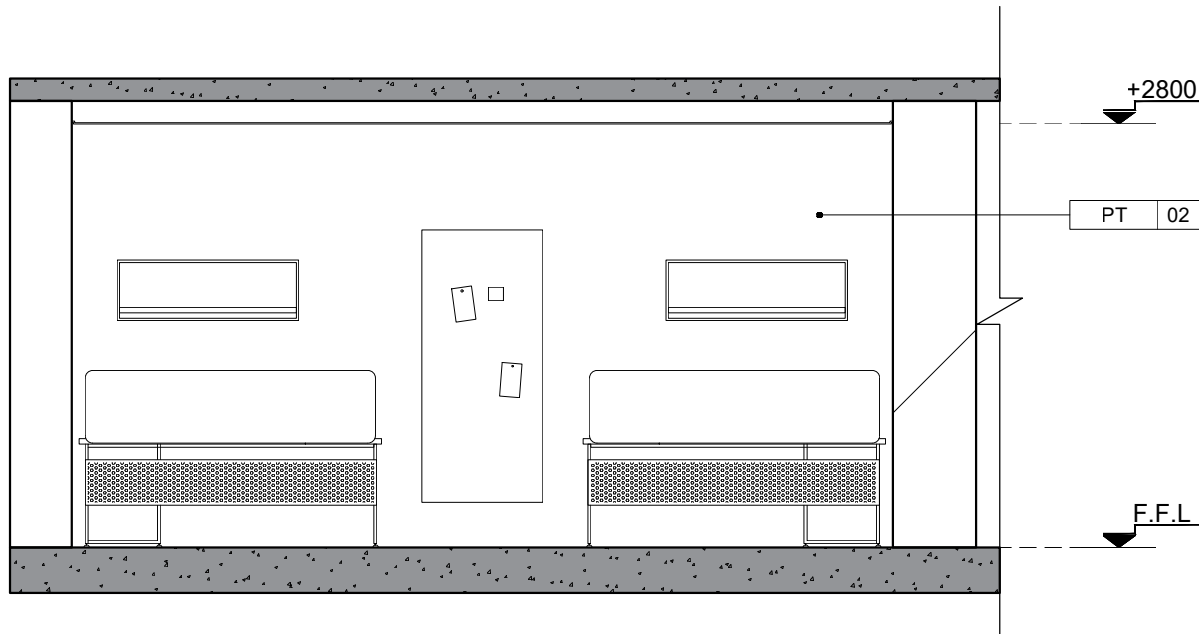

2 Elevation2
UN RC OFFICE YEREVAN SCALE 1:50

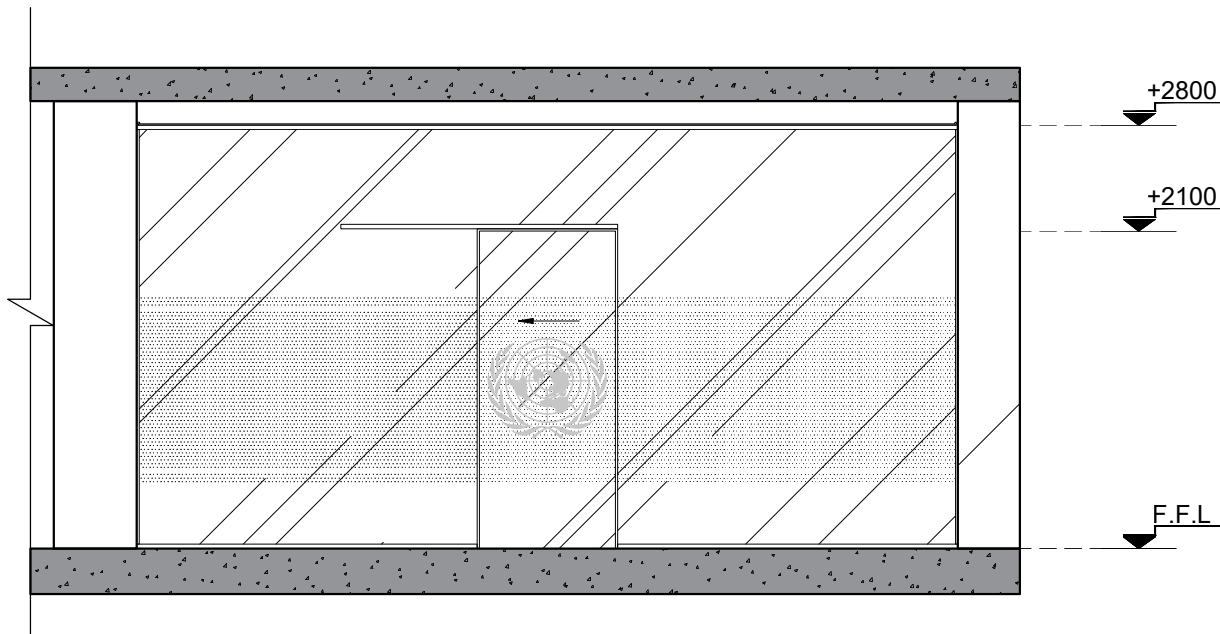

2 ELEVATION 4
UN RC OFFICE YEREVAN SCALE 1:50

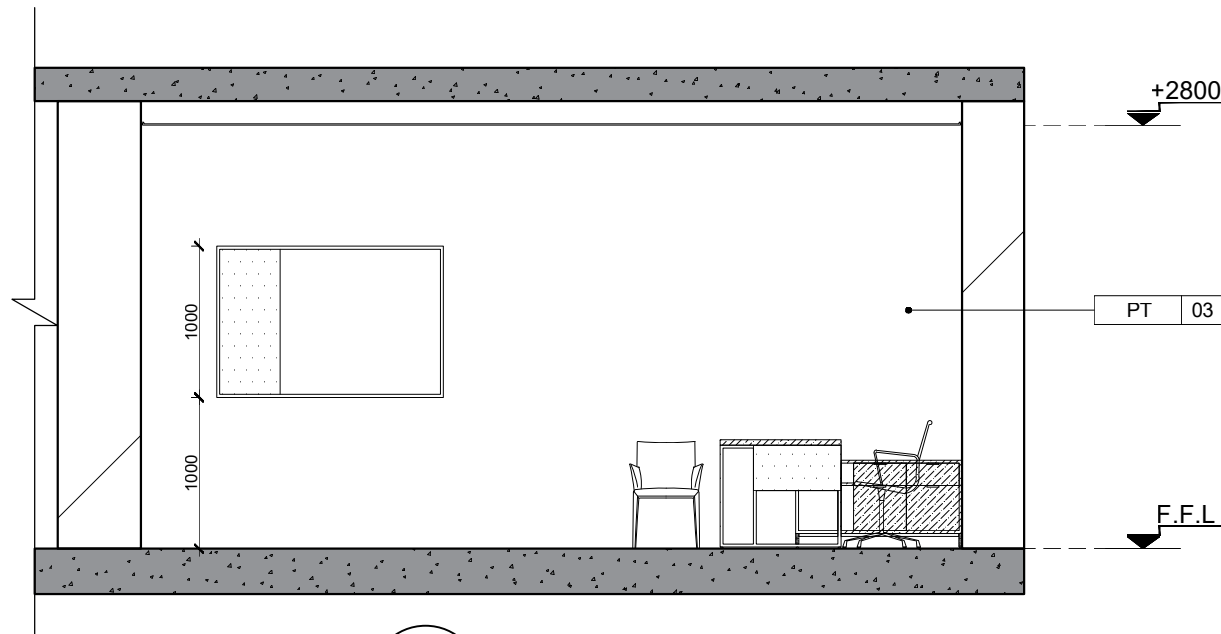

2 ELEVATION 4-a
UN RC OFFICE YEREVAN SCALE 1:50

KEY PLAN



GENERAL NOTES

1. DO NOT SCALE FROM THIS DRAWING.
2. THIS DRAWING MUST BE READ IN CONJUNCTION WITH ALL OTHER RELEVANT DRAWINGS.
3. CONTRACTOR MUST REPORT ANY DISCREPANCIES PRIOR TO EXECUTION OF ANY WORKS.
4. ALL DIMENSIONS MUST BE VERIFIED ON SITE PRIOR TO ORDER OR MANUFACTURE OF MATERIALS OR PRODUCTION OF SHOP DRAWINGS.

REV	DATE	DESCRIPTION	REVISED BY

ISSUE: **FINAL DESIGN**
DESIGN & SUPERVISION CONSULTANT

DESIGN BUILDER

SUB CONTRACTOR

PROJECT

UNDP RC YEREVAN
OFFICES

SHEET TITLE

UN RC ROOM ELEVATIONS

UNDPYO_01907_D0010


APPROVALS

ISSUED BY:	INITIALS	DATE
CHECKED BY:		
INTEGRATED CHECKED BY:		


SCALE

PROJECT NO.

01907

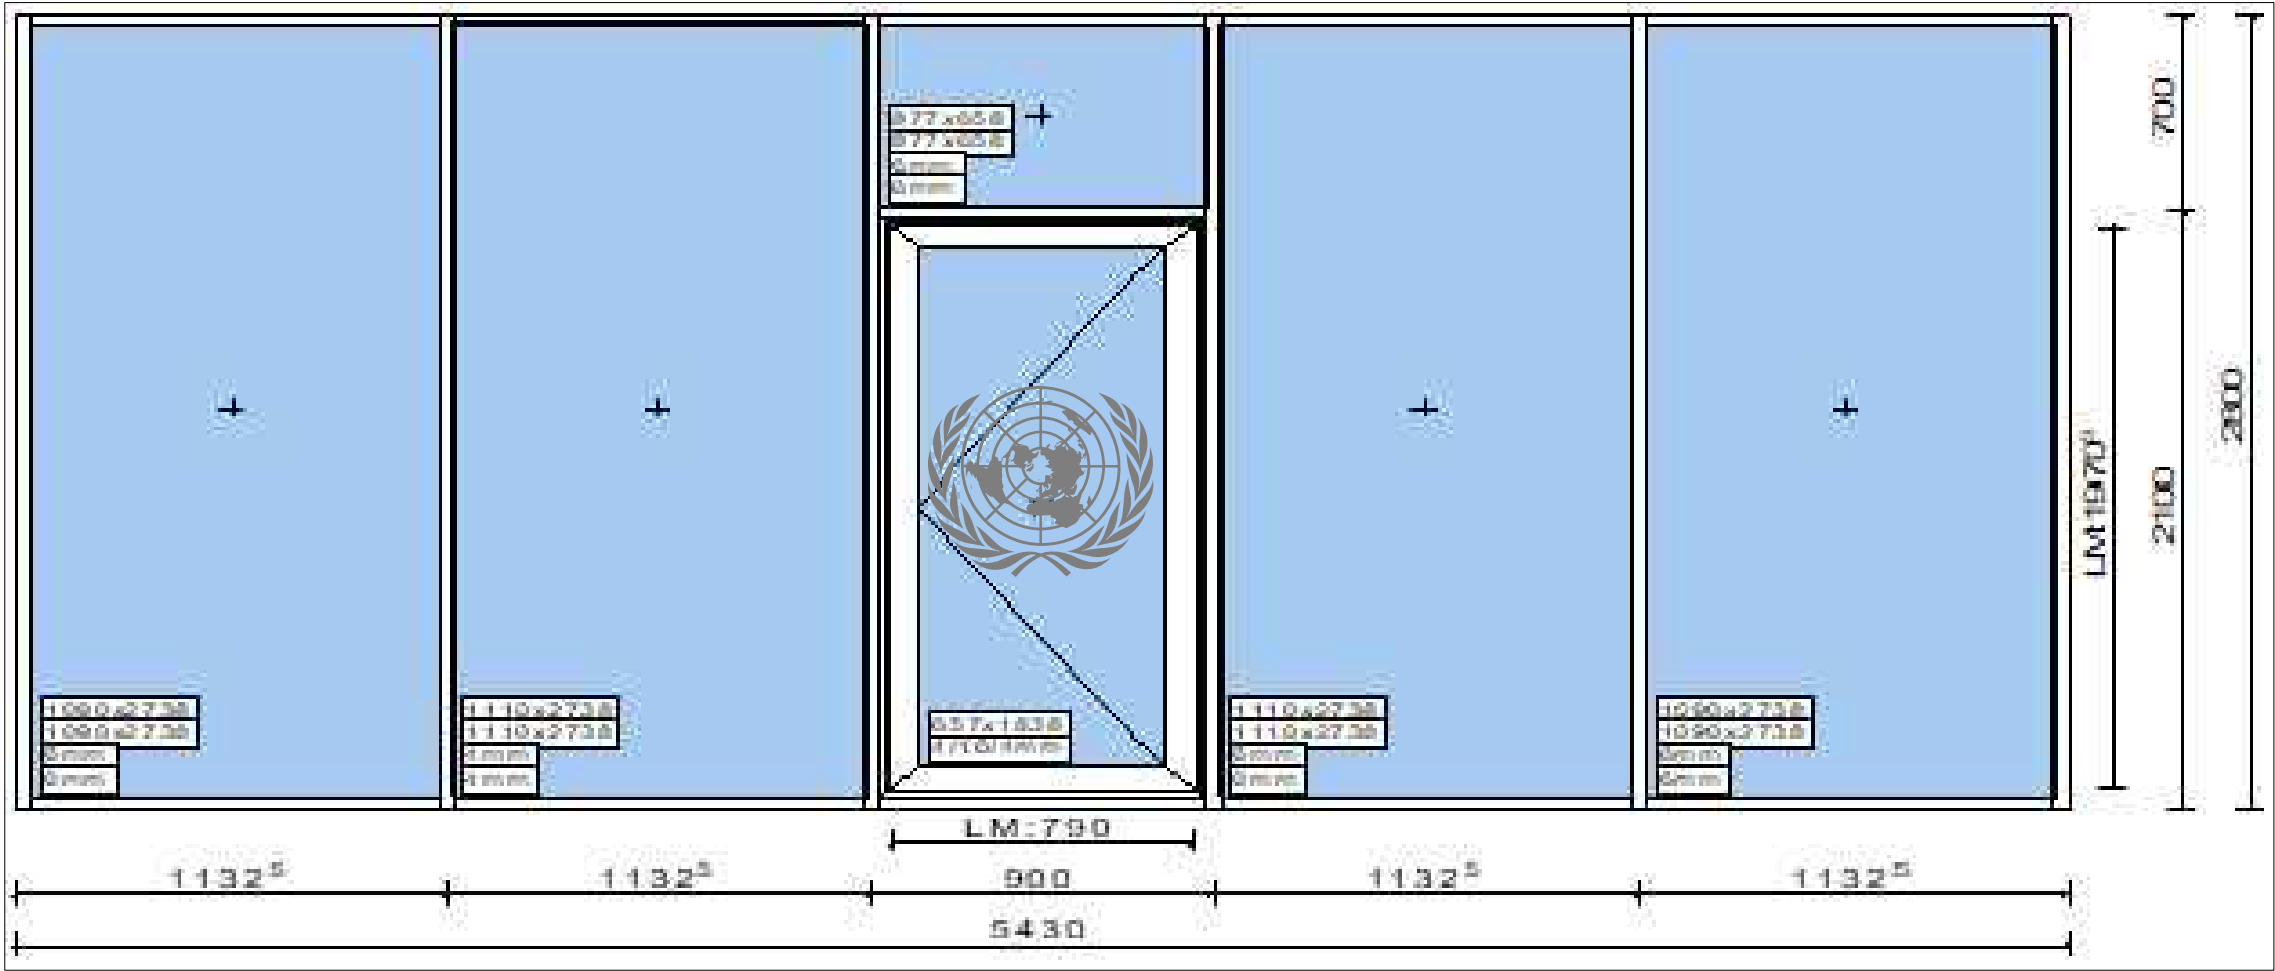

2 Seperating Wall Elevation Option 2
UN RC OFFICE YEREVAN
SCALE 1:50

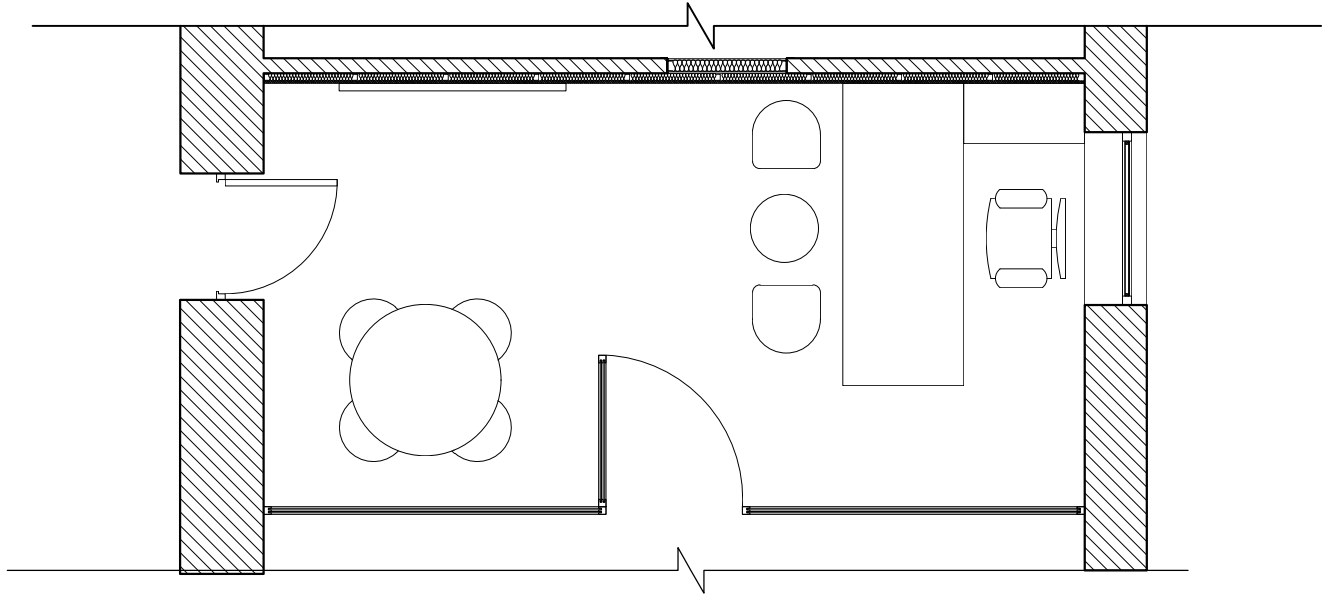

1 Seperating Wall Plan Option 2
UN RC OFFICE YEREVAN
SCALE 1:50

KEY PLAN



GENERAL NOTES

1. DO NOT SCALE FROM THIS DRAWING.
2. THIS DRAWING MUST BE READ IN CONJUNCTION WITH ALL OTHER RELEVANT DRAWINGS.
3. CONTRACTOR MUST REPORT ANY DISCREPANCIES PRIOR TO EXECUTION OF ANY WORKS.
4. ALL DIMENSIONS MUST BE VERIFIED ON SITE PRIOR TO ORDER OR MANUFACTURE OF MATERIALS OR PRODUCTION OF SHOP DRAWINGS.

REV	DATE	DESCRIPTION	REVISED BY
ISSUE: FINAL DESIGN			
DESIGN & SUPERVISION CONSULTANT			

DESIGN BUILDER




SUB CONTRACTOR

PROJECT


UNDP RC YEREVAN
OFFICES

SHEET TITLE
UN RC ROOM SEPERATING
WALL ELEVATION OPTION 2 &
SEPERATING WALL PLAN
OPTION 2
UNDPYO_01907_D003


APPROVALS		
ISSUED BY:	INITIALS	DATE
CHECKED BY:		
INTEGRATED CHECKED BY:		
SCALE	PROJECT NO. 01907	

 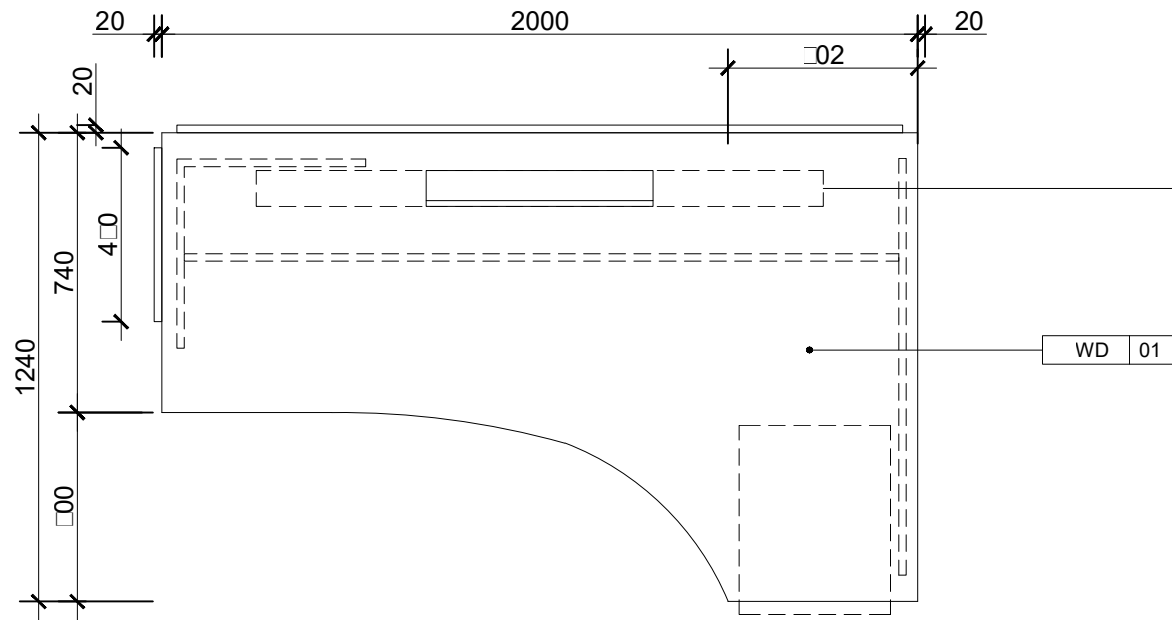 

1 O T T P
UN RC OFFICE YEREVAN SCALE 1:20

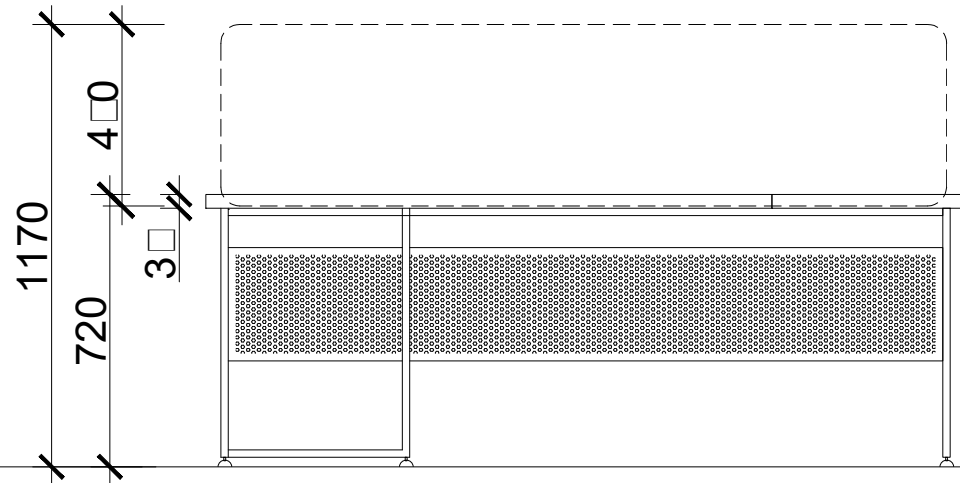

2 O T T E 1
UN RC OFFICE YEREVAN SCALE 1:20

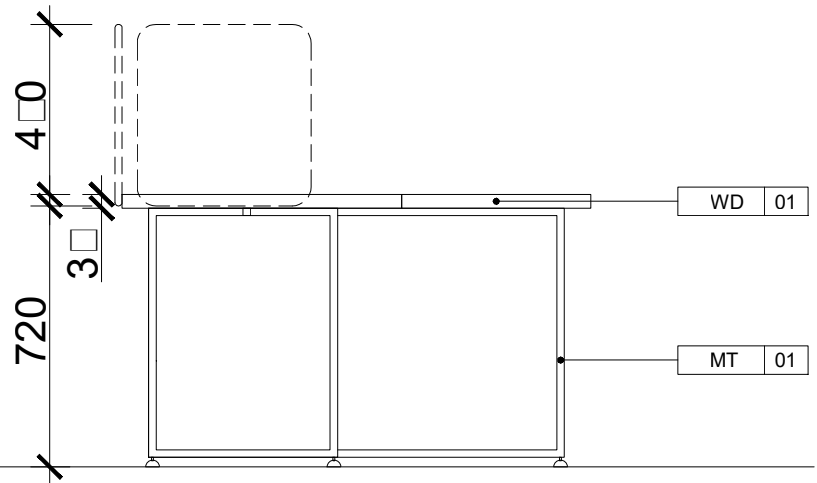

2 O T T E 2
UN RC OFFICE YEREVAN SCALE 1:20

KEY PLAN



GENERAL NOTES

1. DO NOT SCALE FROM THIS DRAWING.
2. THIS DRAWING MUST BE READ IN CONJUNCTION WITH ALL OTHER RELEVANT DRAWINGS.
3. CONTRACTOR MUST REPORT ANY DISCREPANCIES PRIOR TO EXECUTION OF ANY WORKS.
4. ALL DIMENSIONS MUST BE VERIFIED ON SITE PRIOR TO ORDER OR MANUFACTURE OF MATERIALS OR PRODUCTION OF SHOP DRAWINGS.

REV	DATE	DESCRIPTION	REVISED BY
ISSUE: FINAL DESIGN			

DESIGN & SUPERVISION CONSULTANT

DESIGN BUILDER

SUB CONTRACTOR

PROJECT


UNDP RC YEREVAN
OFFICES

SHEET TITLE


UN RC ROOM OFFICE
TYPICAL TABLE
UNDPYO_01907_MD001

APPROVALS

ISSUED BY:	INITIALS	DATE
CHECKED BY:		
INTEGRATED CHECKED BY:		
SCALE		PROJECT NO. 01907

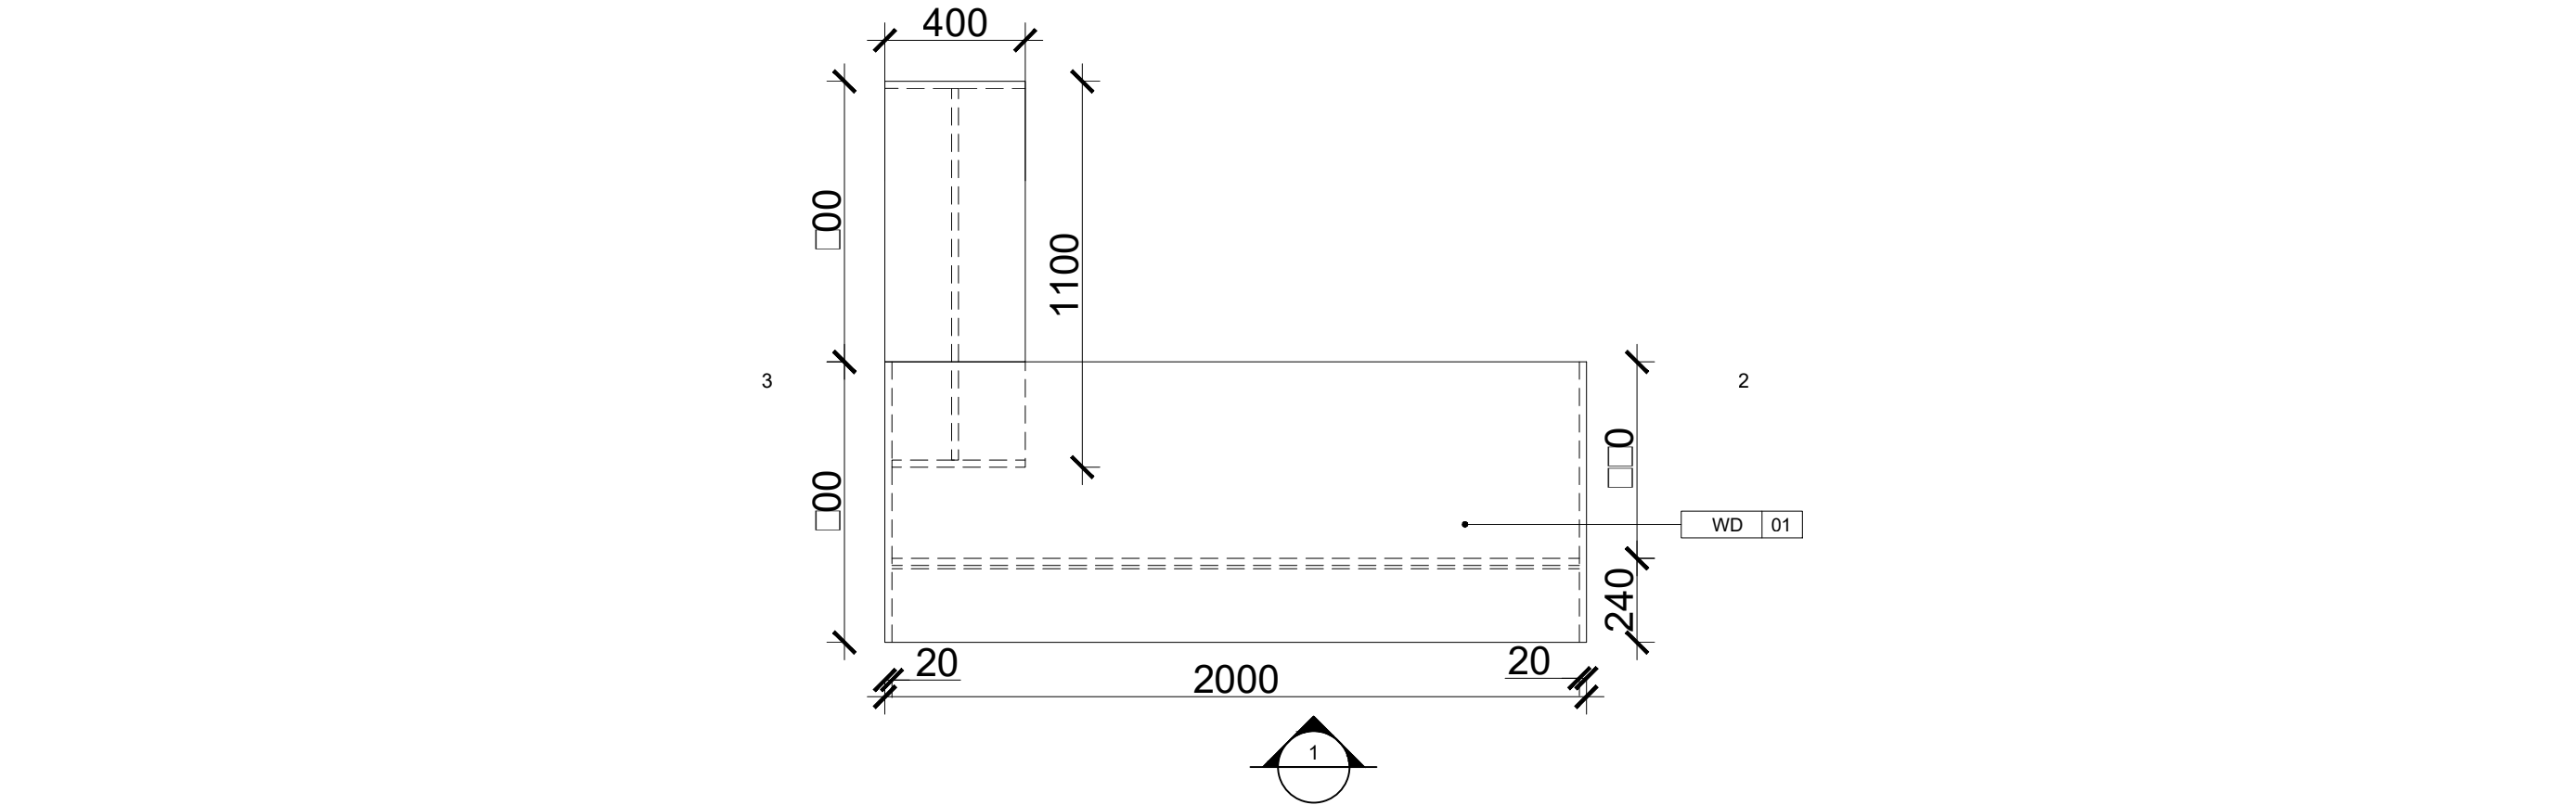

1 O T P
UN RC YEREVAN OFFICE SCALE 1:20

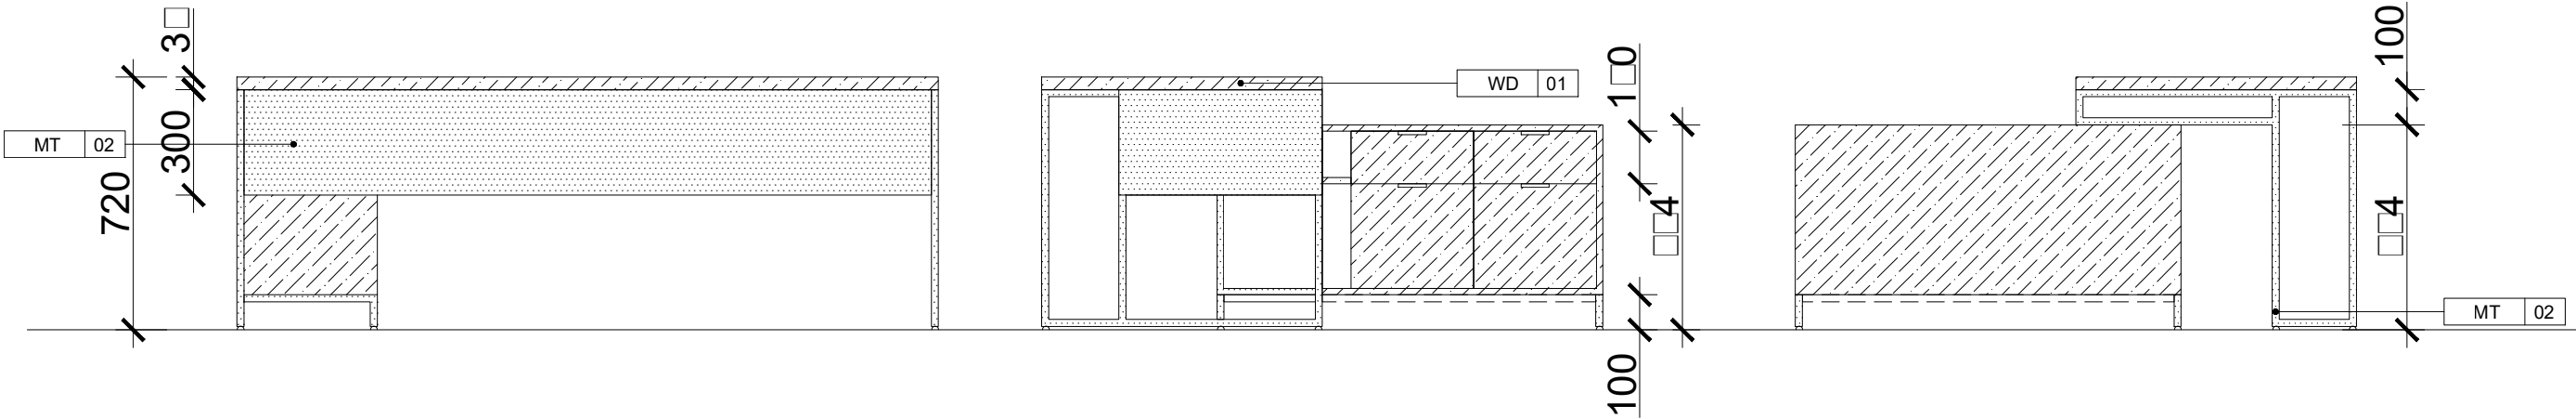

2 O T E 1
UN RC YEREVAN OFFICE SCALE 1:20

2 O T E 2
UN RC YEREVAN OFFICE SCALE 1:20

2 O T E 3
UN RC YEREVAN OFFICE SCALE 1:20

KEY PLAN



GENERAL NOTES

- DO NOT SCALE FROM THIS DRAWING.
- THIS DRAWING MUST BE READ IN CONJUNCTION WITH ALL OTHER RELEVANT DRAWINGS.
- CONTRACTOR MUST REPORT ANY DISCREPANCIES PRIOR TO EXECUTION OF ANY WORKS.
- ALL DIMENSIONS MUST BE VERIFIED ON SITE PRIOR TO ORDER OR MANUFACTURE OF MATERIALS OR PRODUCTION OF SHOP DRAWINGS.

REV	DATE	DESCRIPTION	REVISED BY
ISSUE:		FINAL DESIGN	

DESIGN & SUPERVISION CONSULTANT

DESIGN BUILDER

SUB CONTRACTOR

PROJECT


UNDP RC YEREVAN
OFFICES

SHEET TITLE




UN RC ROOM OFFICE TABLE

UNDPYO_01907_MD002

APPROVALS		
ISSUED BY:	INITIALS	DATE
CHECKED BY:		
INTEGRATED CHECKED BY:		
SCALE	PROJECT NO. 01907	

 

1. DO NOT SCALE FROM THIS DRAWING.
2. THIS DRAWING MUST BE READ IN CONJUNCTION WITH ALL OTHER RELEVANT DRAWINGS.
3. CONTRACTOR MUST REPORT ANY DISCREPANCIES PRIOR TO EXECUTION OF ANY WORKS.
4. ALL DIMENSIONS MUST BE VERIFIED ON SITE PRIOR TO ORDER OR MANUFACTURE OF MATERIALS OR PRODUCTION OF SHOP DRAWINGS.

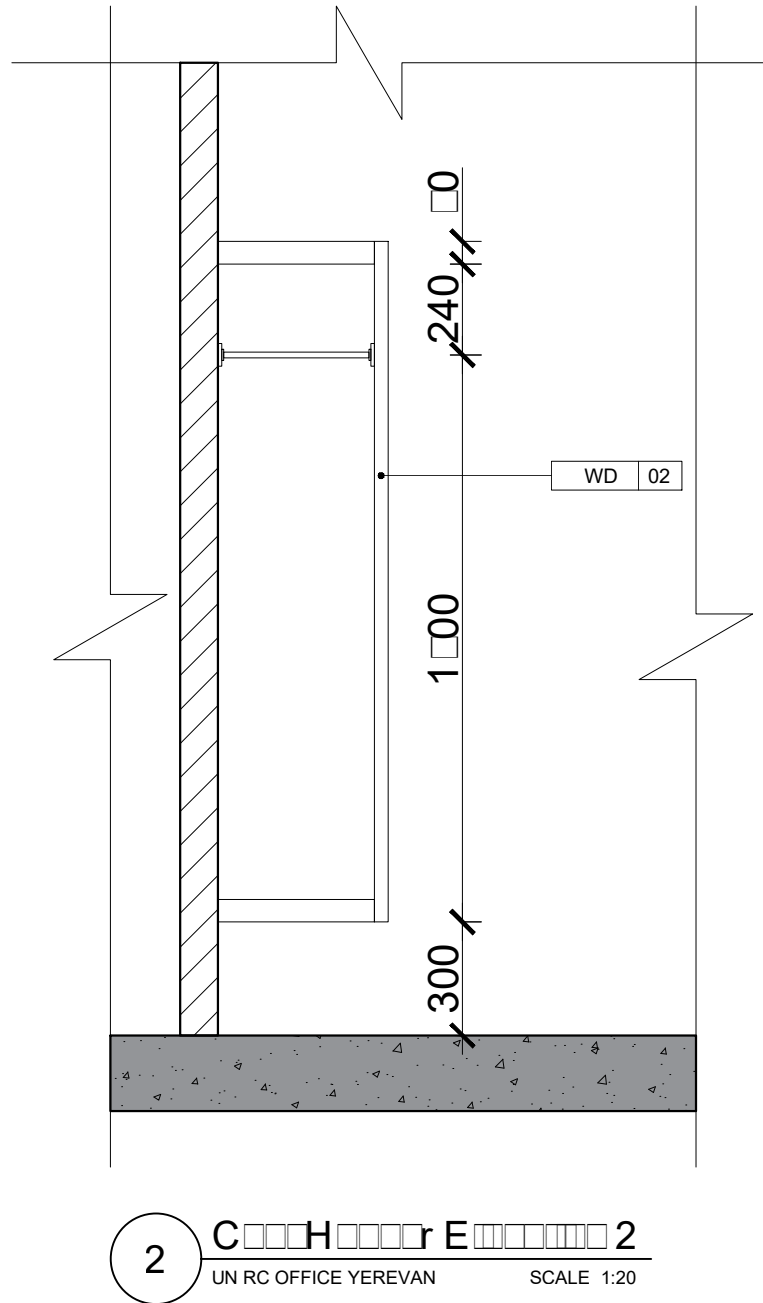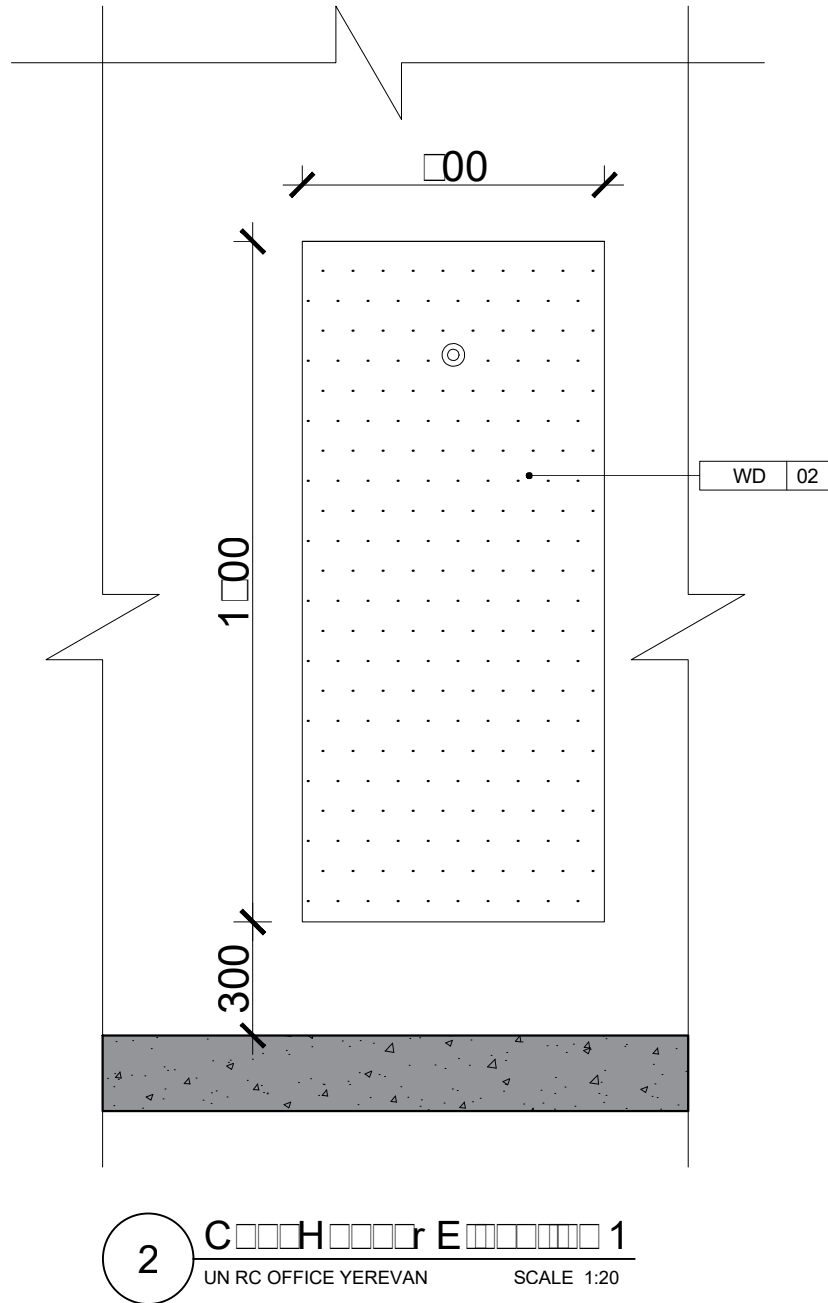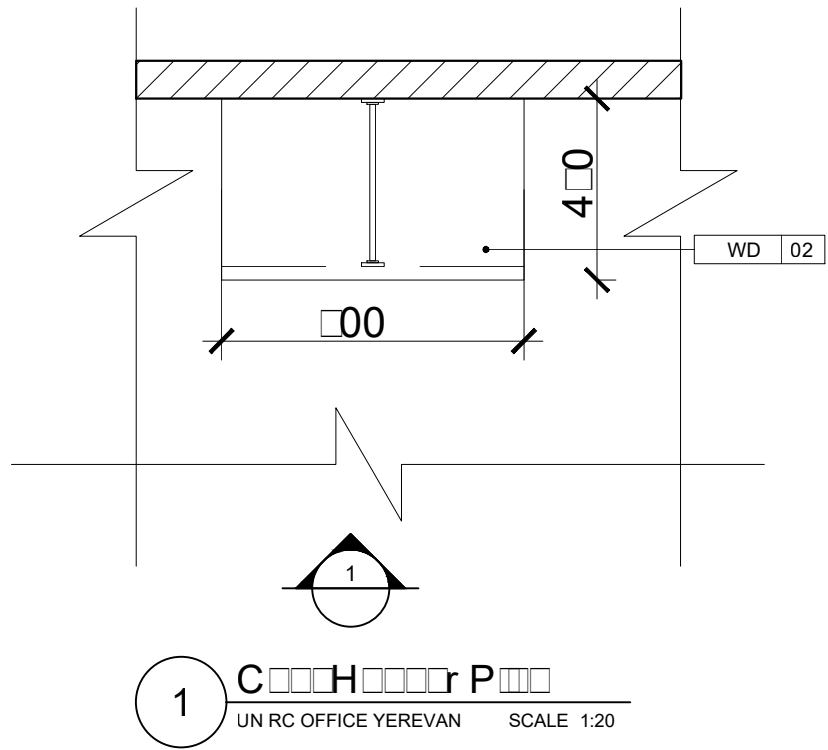

KEY PLAN

DZ

architectural
design studio

NORTH

GENERAL NOTES

1. DO NOT SCALE FROM THIS DRAWING.

2. THIS DRAWING MUST BE READ IN CONJUNCTION WITH ALL OTHER RELEVANT DRAWINGS.

3. CONTRACTOR MUST REPORT ANY DISCREPANCIES PRIOR TO EXECUTION OF ANY WORKS.

4. ALL DIMENSIONS MUST BE VERIFIED ON SITE PRIOR TO ORDER OR MANUFACTURE OF MATERIALS OR PRODUCTION OF SHOP DRAWINGS.

REV	DATE	DESCRIPTION	REVISED BY
ISSUE: FINAL DESIGN			
DESIGN & SUPERVISION CONSULTANT			

DESIGN BUILDER

SUB CONTRACTOR

PROJECT


UNDP RC YEREVAN OFFICES

SHEET TITLE

UN RC ROOM COAT HANGER


UNDPYO_01907_MD004

APPROVALS		INITIALS	DATE
ISSUED BY:			
CHECKED BY:			
INTEGRATED CHECKED BY:			
SCALE	PROJECT NO. 01907		

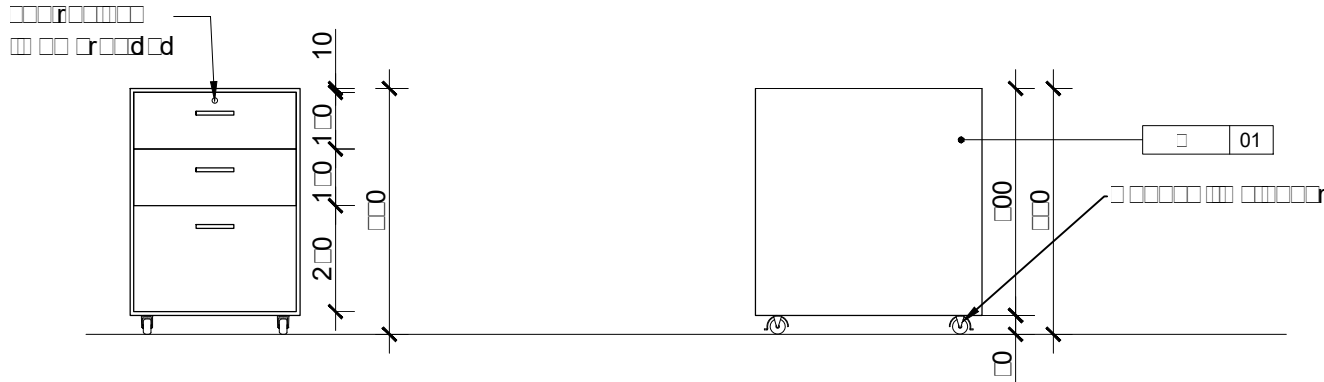


2 O Dr r E 1
UN RC OFFICE YEREVAN SCALE 1:20


2 O Dr r E 2
UN RC OFFICE YEREVAN SCALE 1:20

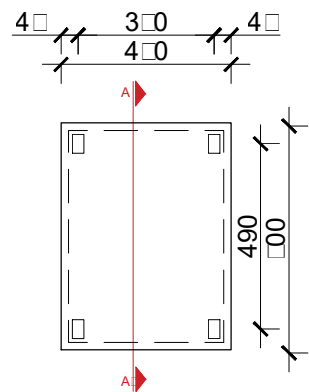


1 O Dr r
UN RC OFFICE YEREVAN SCALE 1:20

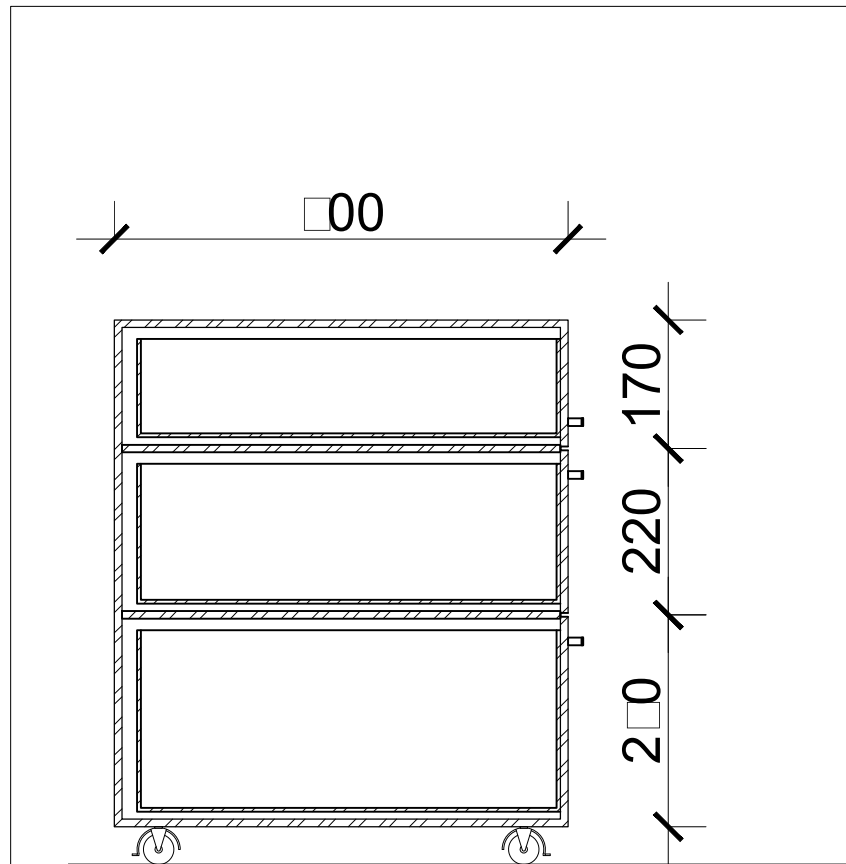


3 S AA
UN RC OFFICE YEREVAN SCALE 1:10

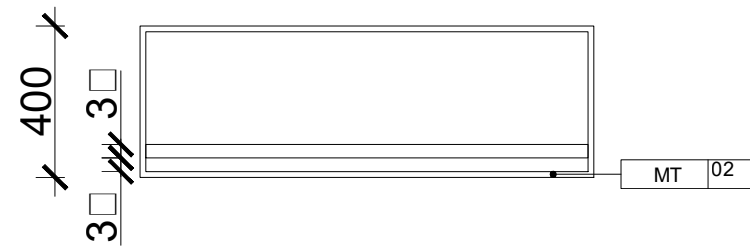

2 W S E 1
UN RC OFFICE YEREVAN SCALE 1:20

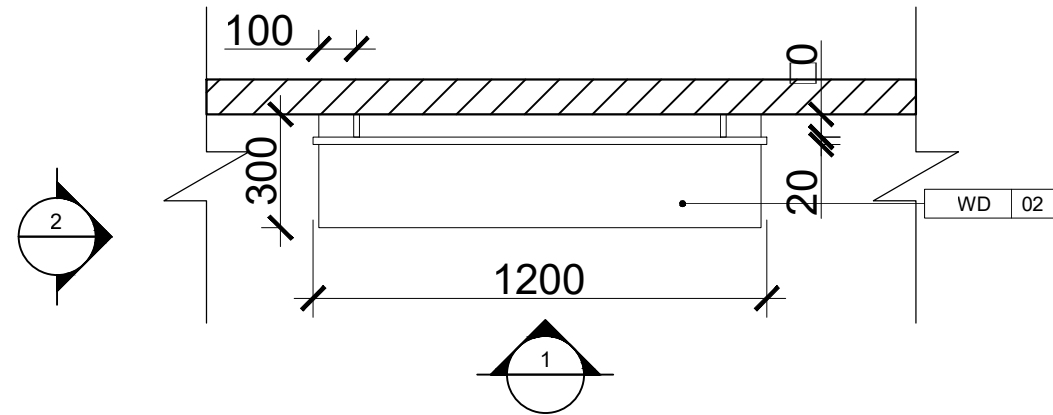

1 W S P
UN RC OFFICE YEREVAN SCALE 1:20

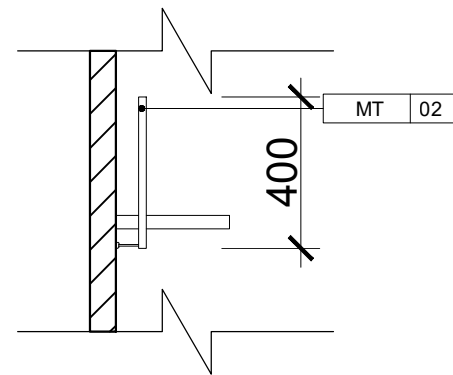

2 W S E 2
UN RC OFFICE YEREVAN SCALE 1:20

KEY PLAN



GENERAL NOTES

- DO NOT SCALE FROM THIS DRAWING.
- THIS DRAWING MUST BE READ IN CONJUNCTION WITH ALL OTHER RELEVANT DRAWINGS.
- CONTRACTOR MUST REPORT ANY DISCREPANCIES PRIOR TO EXECUTION OF ANY WORKS.
- ALL DIMENSIONS MUST BE VERIFIED ON SITE PRIOR TO ORDER OR MANUFACTURE OF MATERIALS OR PRODUCTION OF SHOP DRAWINGS.

REV	DATE	DESCRIPTION	REVISED BY
ISSUE: FINAL DESIGN			

DESIGN & SUPERVISION CONSULTANT

DESIGN BUILDER

SUB CONTRACTOR


PROJECT

UNDP RC YEREVAN
OFFICES


SHEET TITLE

UN RC ROOM OFFICE
DRAWER & WALL SHELF
UNDPYO_01907_MD00


APPROVALS		
ISSUED BY:	INITIALS	DATE
CHECKED BY:		
INTEGRATED CHECKED BY:		
SCALE	PROJECT NO. 01907	

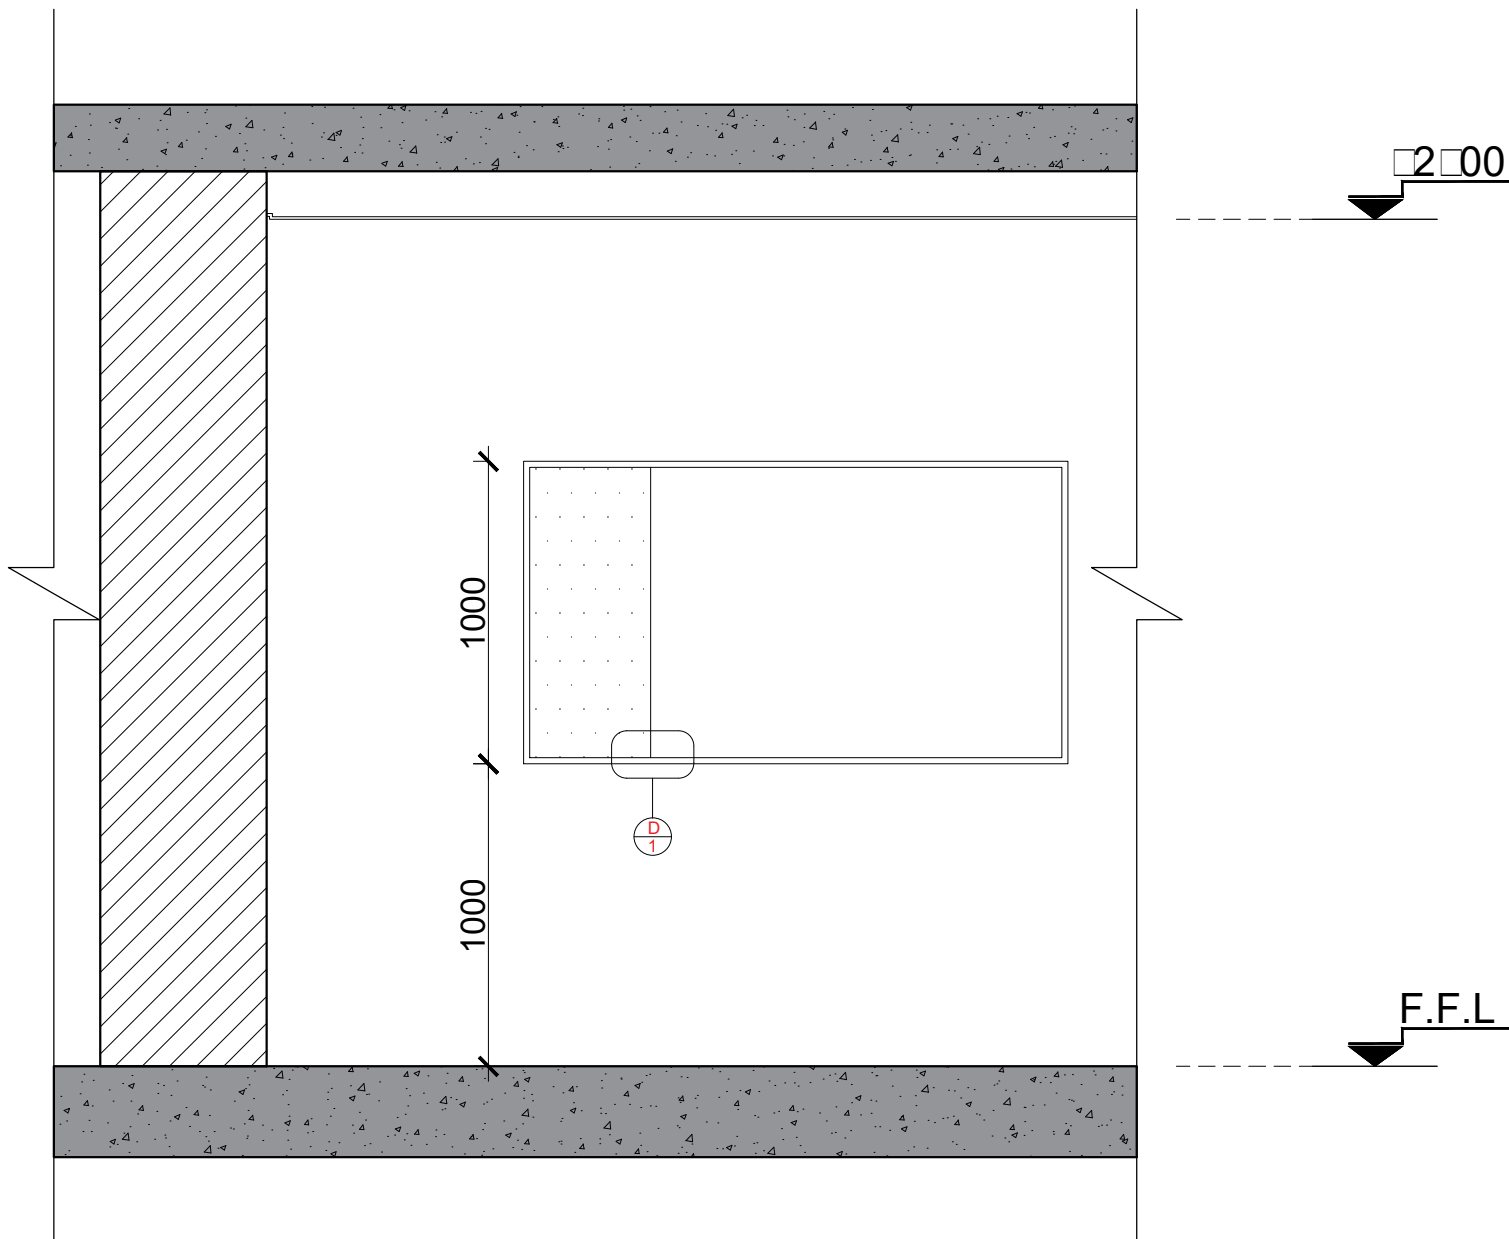

2 ELEVATION 400
UN RC OFFICE YEREVAN SCALE 1:20

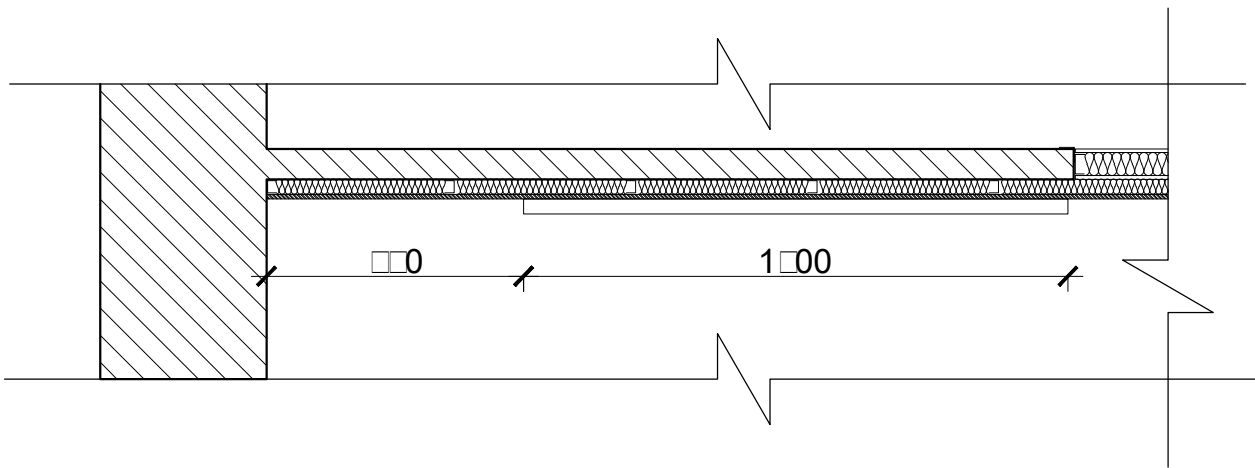

1 W0000 B00rd P000
UN RC OFFICE YEREVAN SCALE 1:20

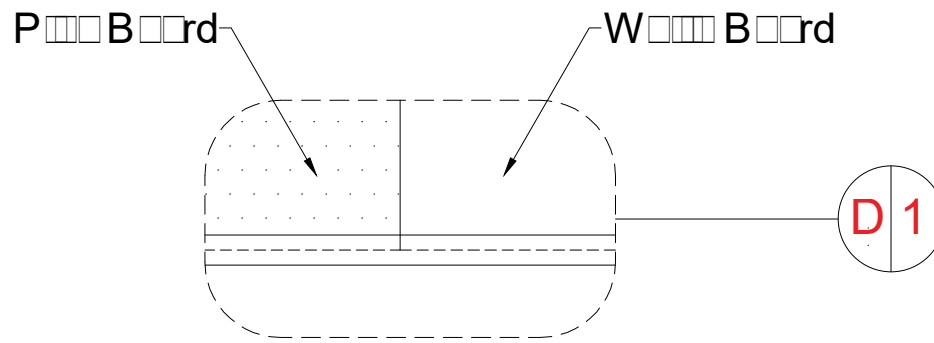

4 D000001
UNDP Y00000 O00000 SCALE 1:20

KEY PLAN

GENERAL NOTES

1. DO NOT SCALE FROM THIS DRAWING.

2. THIS DRAWING MUST BE READ IN CONJUNCTION WITH ALL OTHER RELEVANT DRAWINGS.

3. CONTRACTOR MUST REPORT ANY DISCREPANCIES PRIOR TO EXECUTION OF ANY WORKS.

4. ALL DIMENSIONS MUST BE VERIFIED ON SITE PRIOR TO ORDER OR MANUFACTURE OF MATERIALS OR PRODUCTION OF SHOP DRAWINGS.

REV	DATE	DESCRIPTION	REVISED BY
ISSUE:	FINAL DESIGN		
DESIGN & SUPERVISION CONSULTANT			

DESIGN BUILDER

SUB CONTRACTOR

PROJECT

UNDP RC YEREVAN OFFICES

SHEET TITLE

UN RC ROOM WRITING BOARD

UNDPYO_01907_MD00

APPROVALS		INITIALS	DATE
ISSUED BY:			
CHECKED BY:			
INTEGRATED CHECKED BY:			
SCALE	PROJECT NO. 01907		



KEY PLAN



GENERAL NOTES

1. DO NOT SCALE FROM THIS DRAWING.
2. THIS DRAWING MUST BE READ IN CONJUNCTION WITH ALL OTHER RELEVANT DRAWINGS.
3. CONTRACTOR MUST REPORT ANY DISCREPANCIES PRIOR TO EXECUTION OF ANY WORKS.
4. ALL DIMENSIONS MUST BE VERIFIED ON SITE PRIOR TO ORDER OR MANUFACTURE OF MATERIALS OR PRODUCTION OF SHOP DRAWINGS.

REV	DATE	DESCRIPTION	REVISED BY
ISSUE: FINAL DESIGN			
DESIGN & SUPERVISION CONSULTANT			

DESIGN BUILDER

SUB CONTRACTOR

PROJECT

UNDP RC YEREVAN
OFFICES

SHEET TITLE

UN RC ROOM VISUAL A

UNDPYO_01907_V001

APPROVALS

ISSUED BY:	INITIALS	DATE
CHECKED BY:		
INTEGRATED CHECKED BY:		

SCALE

PROJECT NO.
01907



KEY PLAN



GENERAL NOTES

1. DO NOT SCALE FROM THIS DRAWING.
2. THIS DRAWING MUST BE READ IN CONJUNCTION WITH ALL OTHER RELEVANT DRAWINGS.
3. CONTRACTOR MUST REPORT ANY DISCREPANCIES PRIOR TO EXECUTION OF ANY WORKS.
4. ALL DIMENSIONS MUST BE VERIFIED ON SITE PRIOR TO ORDER OR MANUFACTURE OF MATERIALS OR PRODUCTION OF SHOP DRAWINGS.

REV	DATE	DESCRIPTION	REVISED BY
ISSUE: FINAL DESIGN			
DESIGN & SUPERVISION CONSULTANT			

DESIGN BUILDER

SUB CONTRACTOR

PROJECT

UNDP RC YEREVAN
OFFICES

SHEET TITLE

UN RC ROOM VISUAL B

UNDPYO_01907_V002

APPROVALS		
ISSUED BY:	INITIALS	DATE
CHECKED BY:		
INTEGRATED CHECKED BY:		

SCALE PROJECT NO.
01907

25 Tumanyan
Yerevan Armenia
info@dzinteriors.design
ARM +(374) 94 425 431

CYP +(357) 97 620 452

www.dzinteriors.design