




Annex-1 (Drawings) – 18th Floor

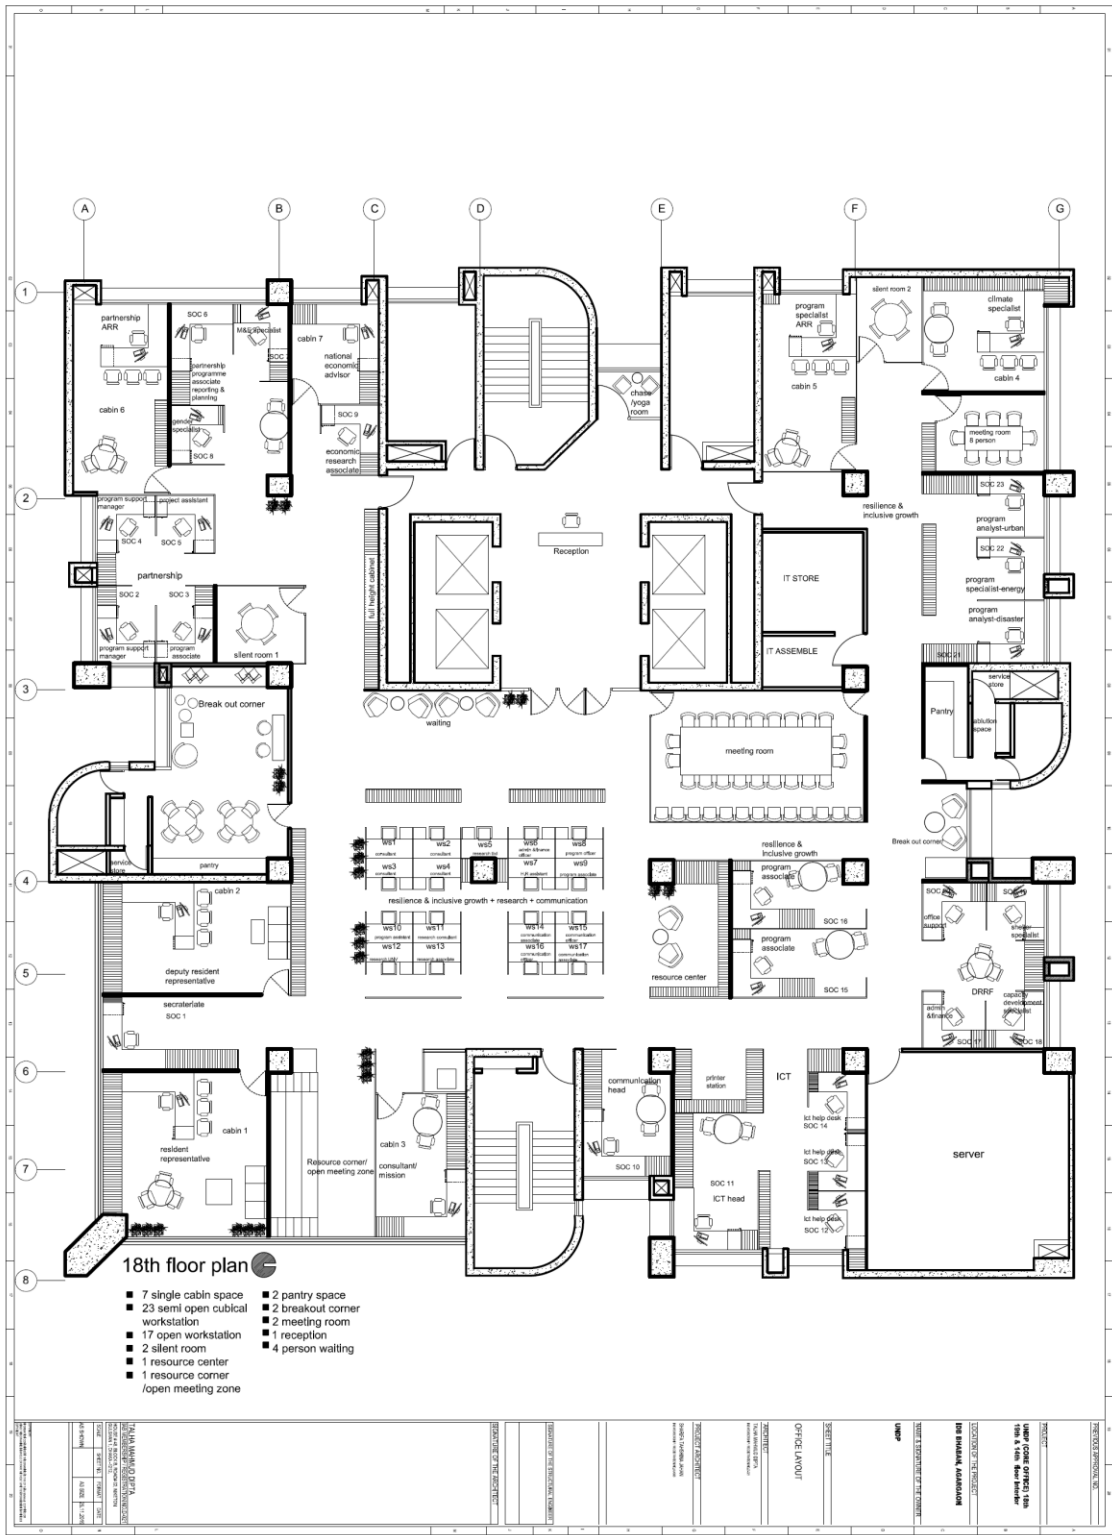


19th Floor

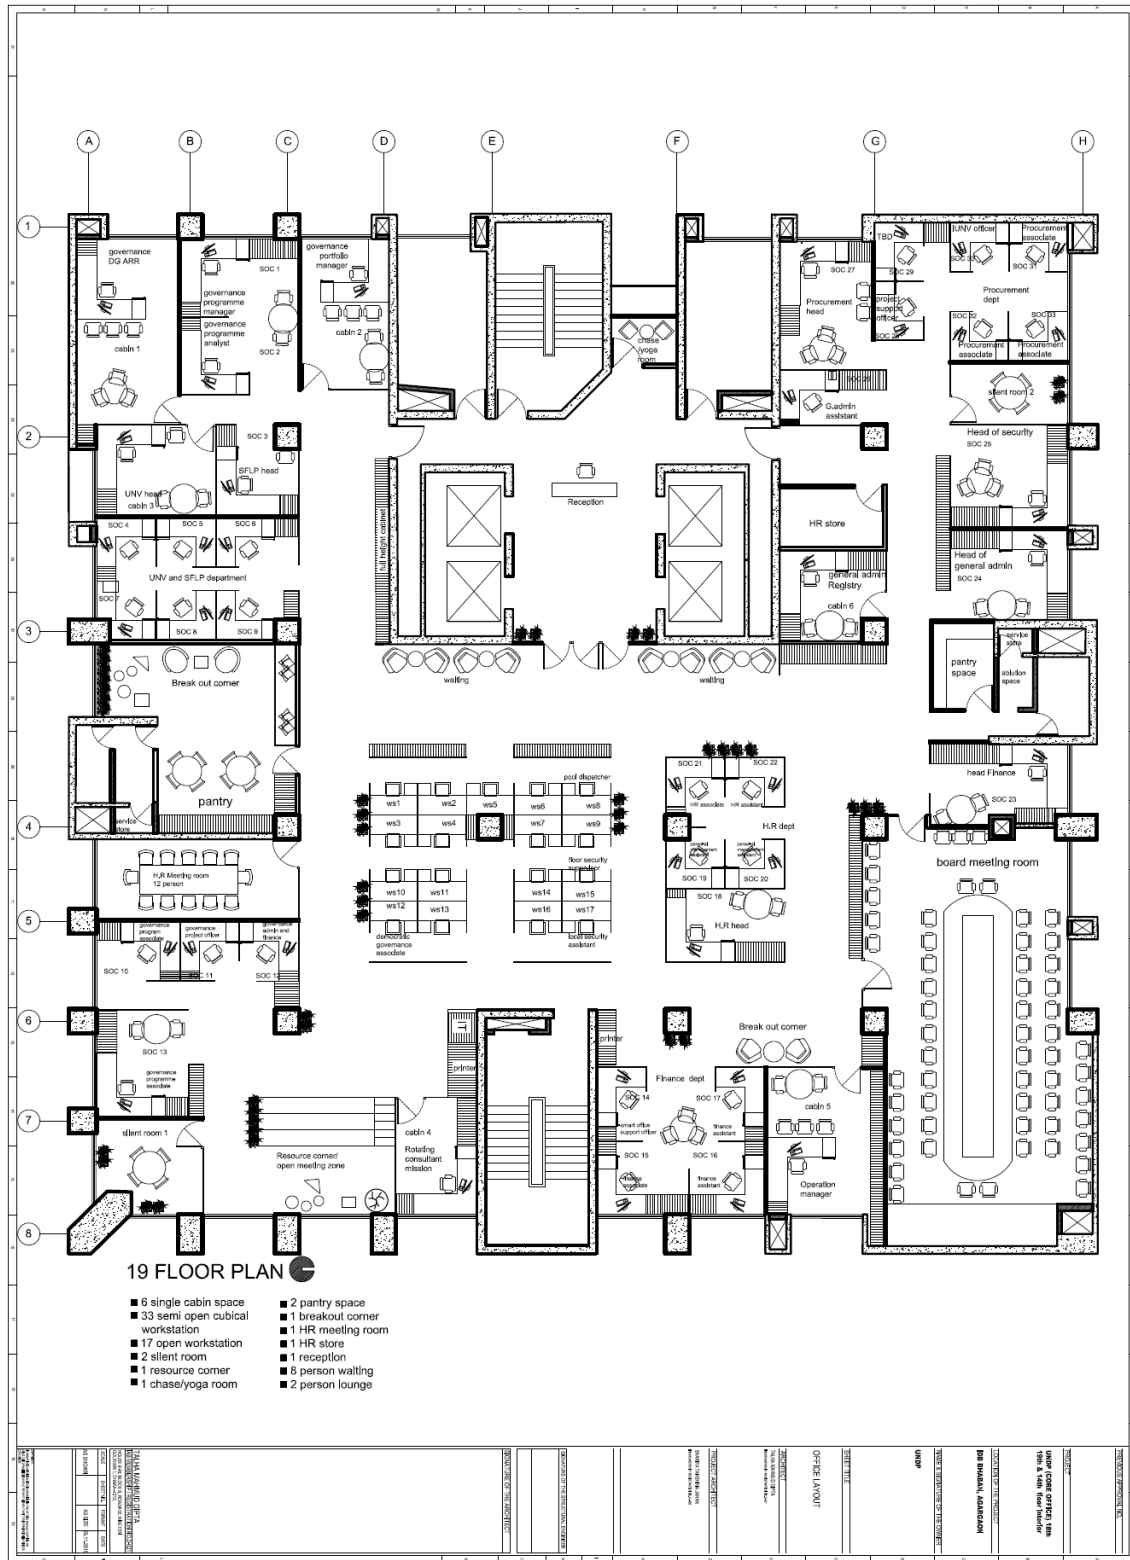


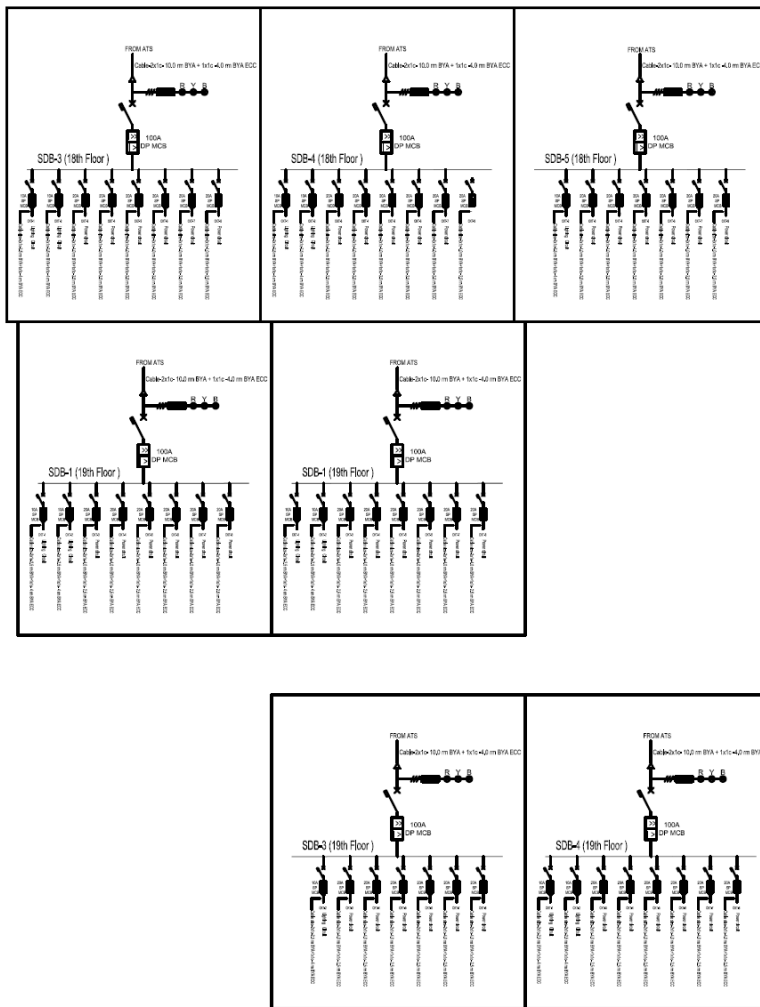



ELECTRICAL CIRCUIT DIAGRAM (SINGLE LINE DIAGRAM)

[illegible]

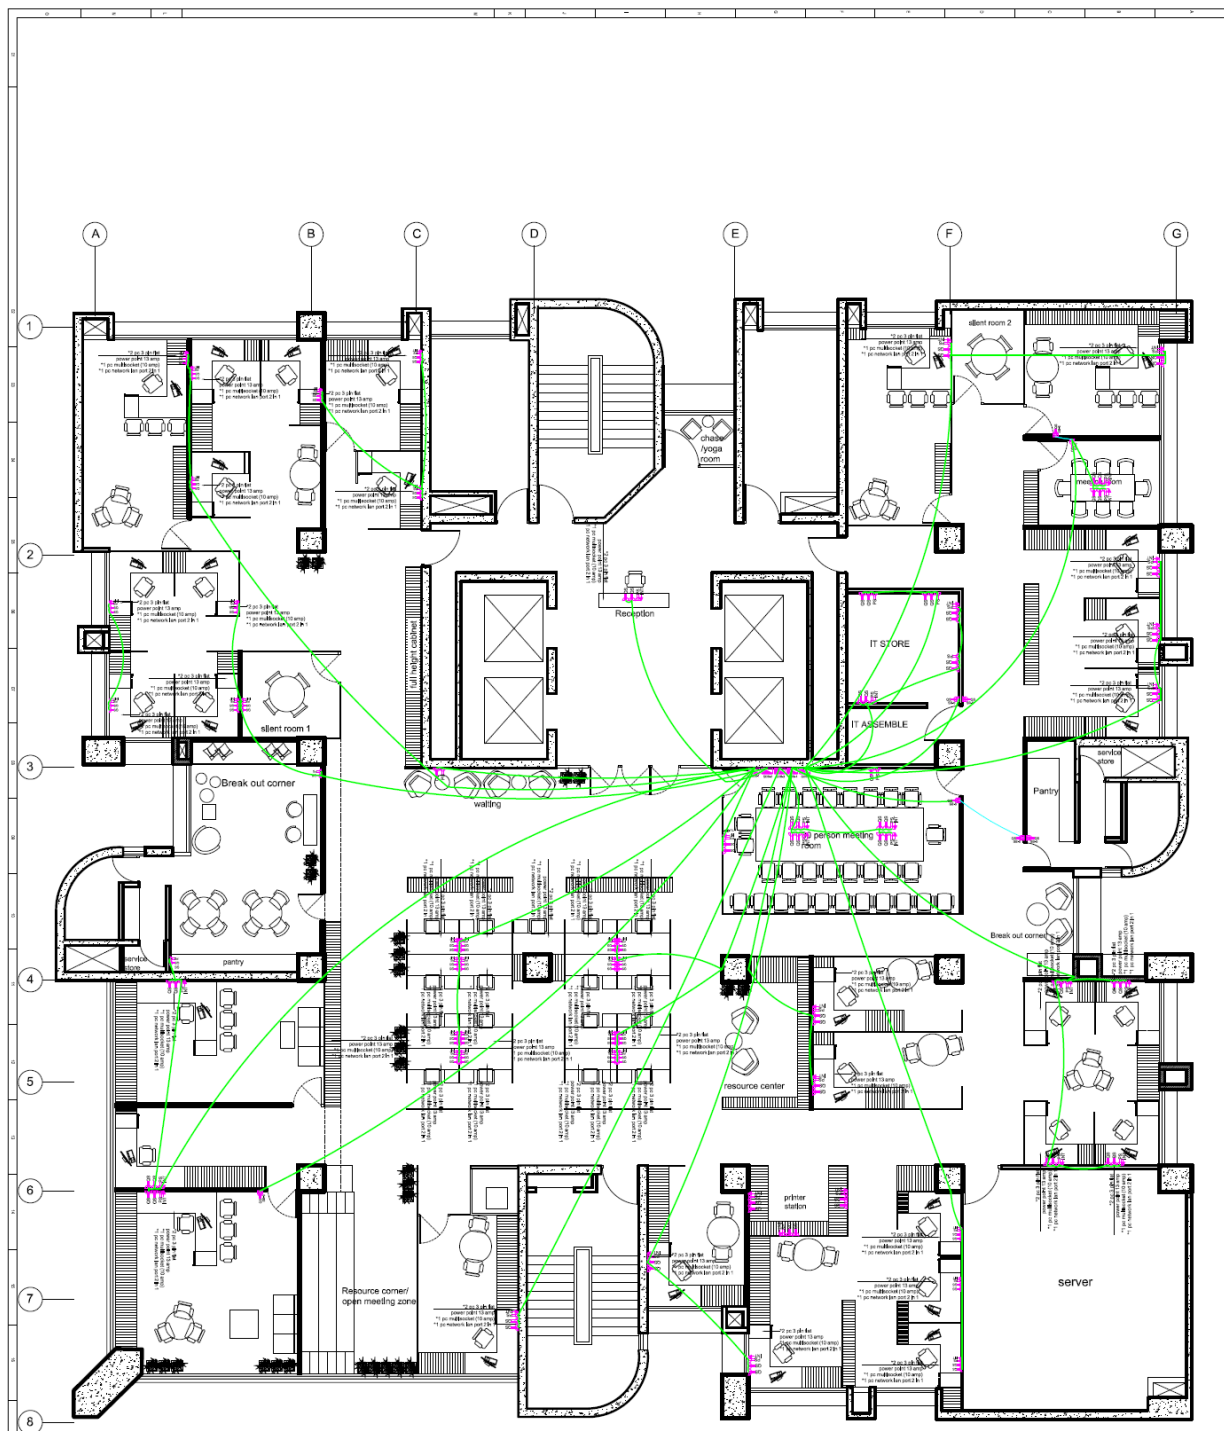[illegible]

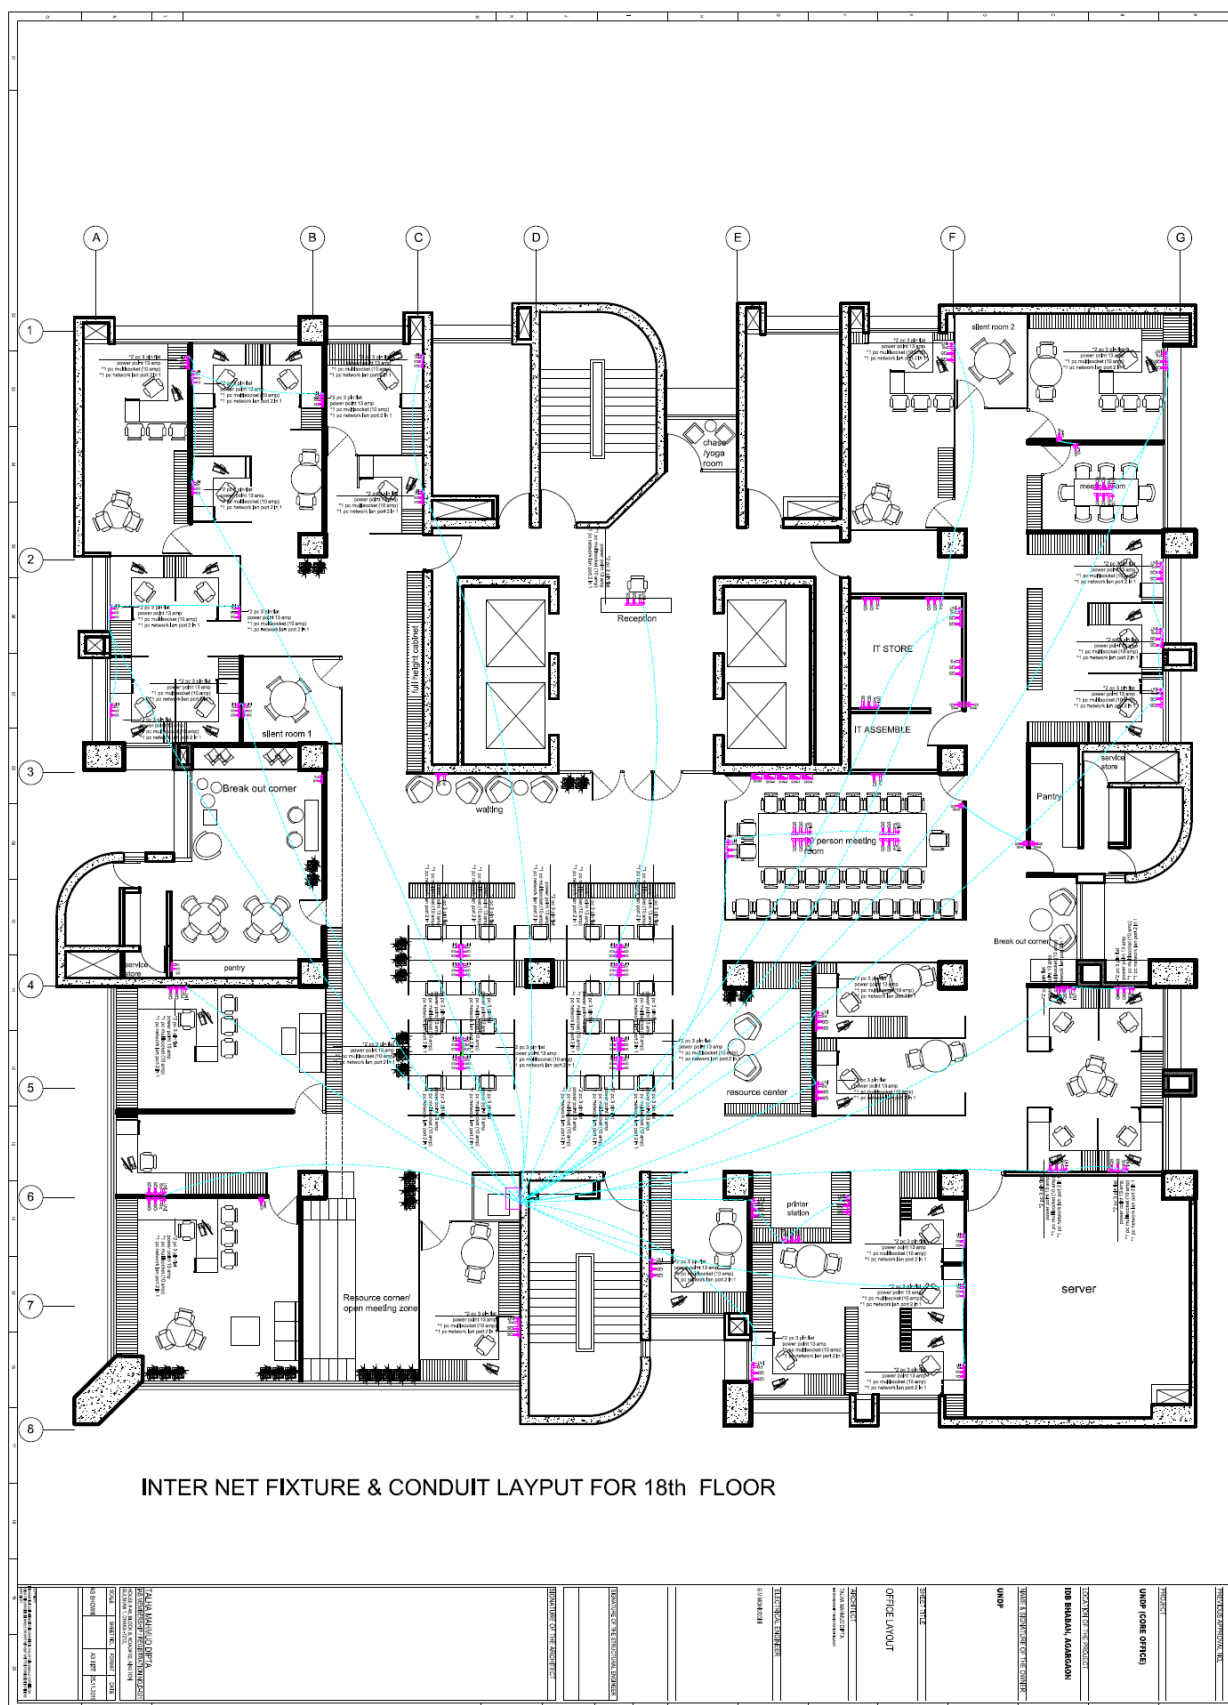

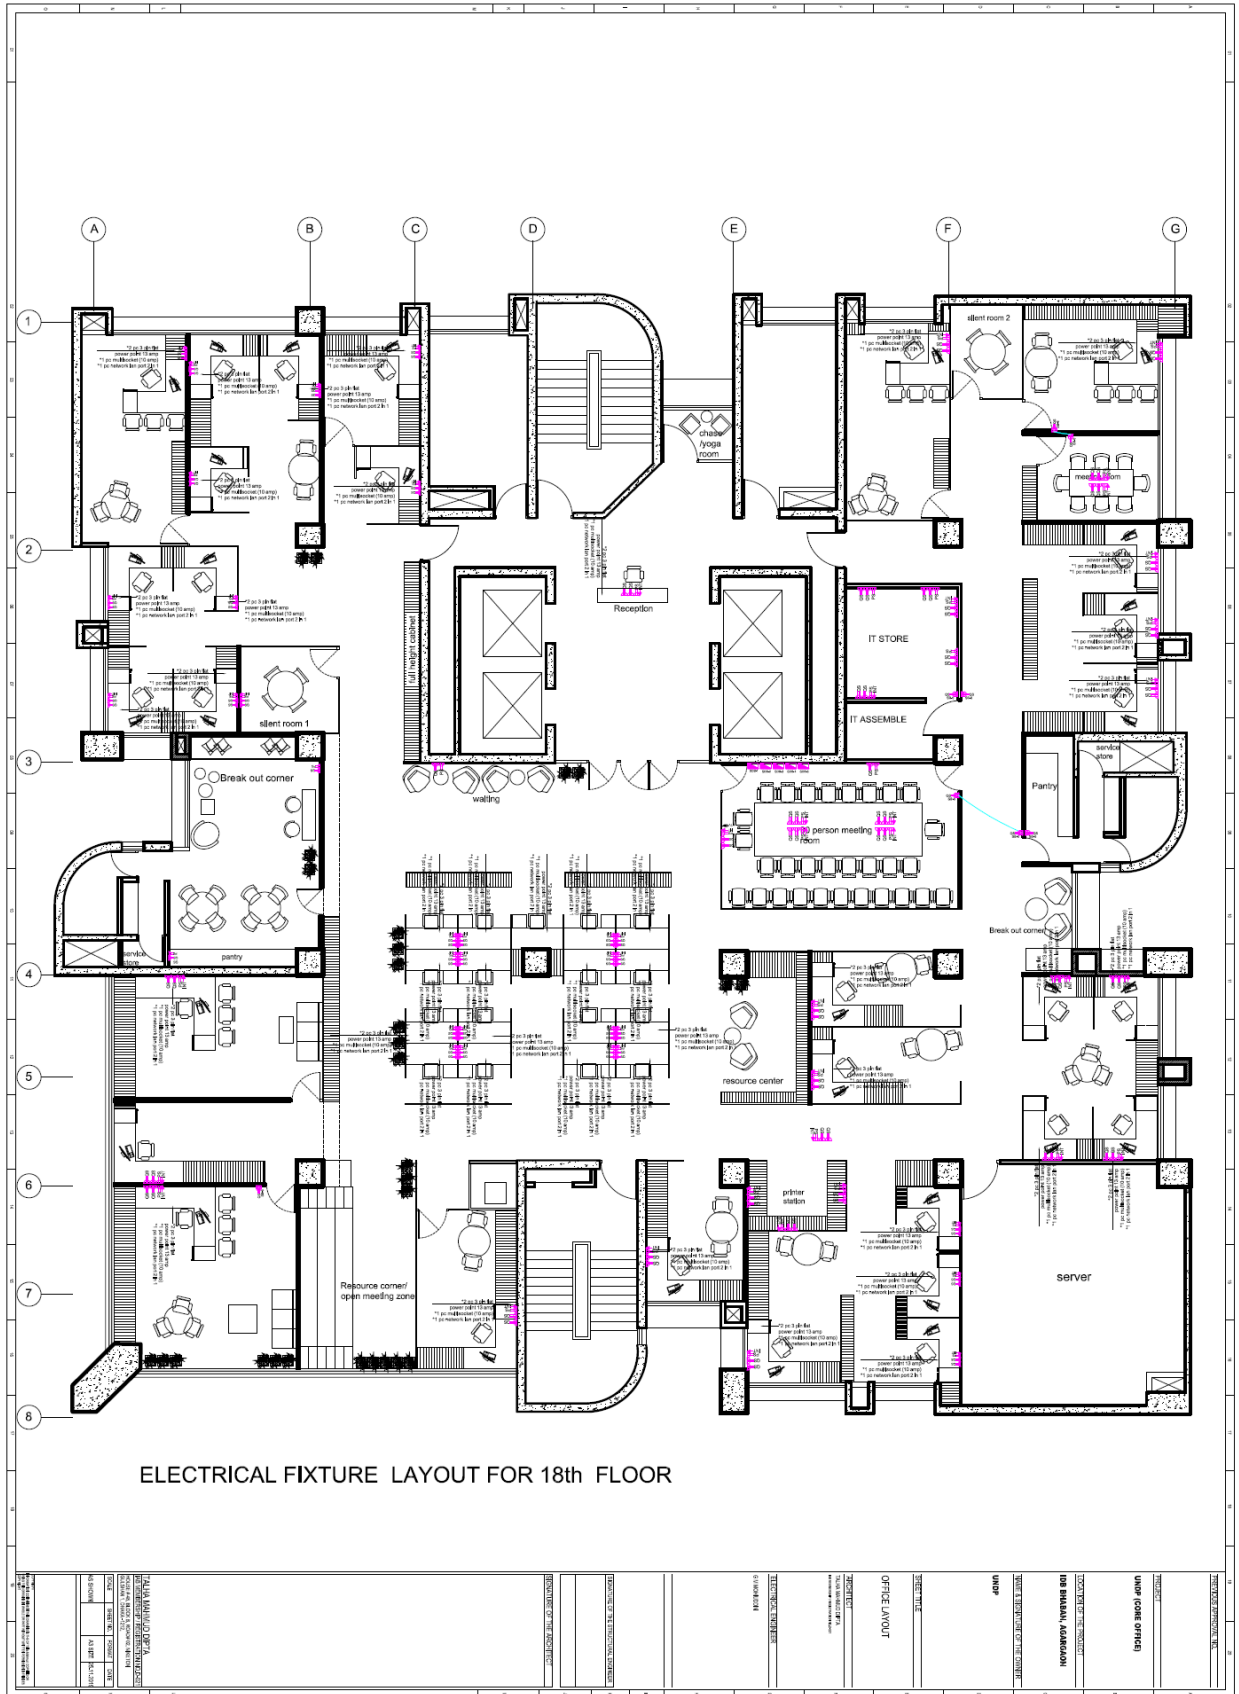

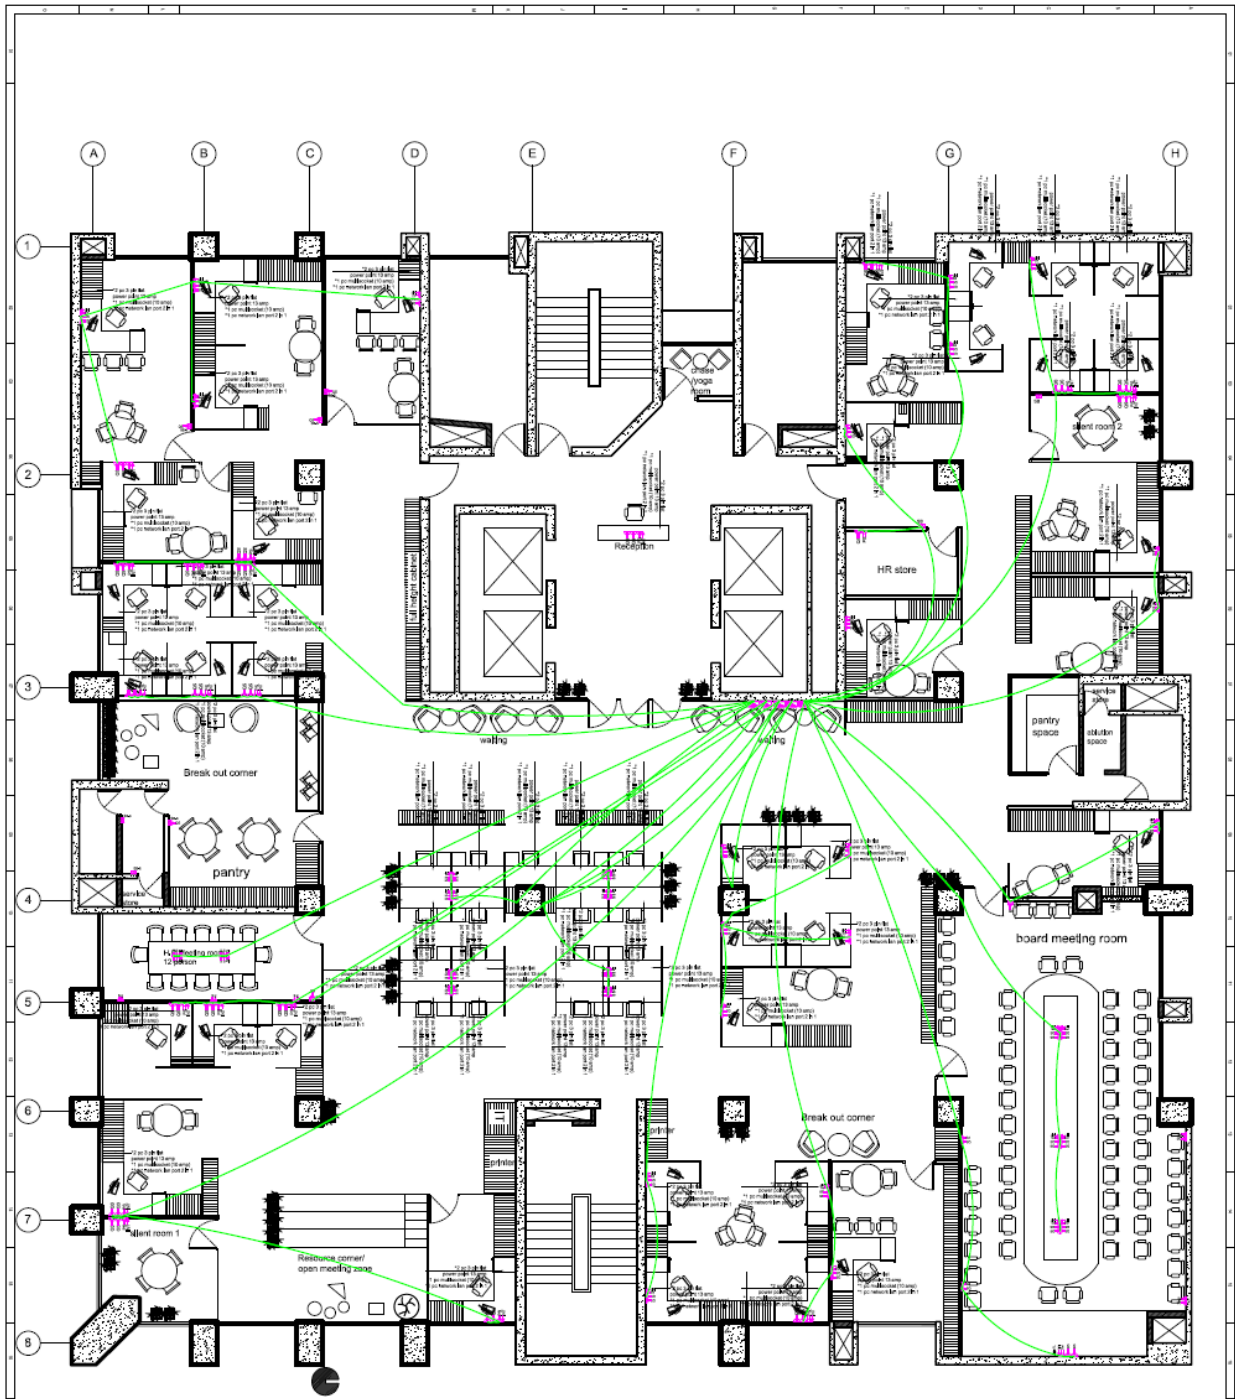

ELECTRICAL FIXTURE & CONDUIT LAYOUT FOR 19th FLOOR

DATE: 10/10/2018		PROJECT: 19th FLOOR		DESIGNER: [Name]		CHECKER: [Name]		APPROVER: [Name]	
REVISIONS:									
NO.	DESCRIPTION	DATE							
1	ISSUED FOR PERMIT	10/10/2018							

NOTES:

1. ALL WORK SHALL BE IN ACCORDANCE WITH THE 2014 NATIONAL ELECTRICAL CODE (NEC) AND THE 2014 CALIFORNIA ELECTRICAL CODE (CEC).

2. ALL WORK SHALL BE IN ACCORDANCE WITH THE 2014 INTERNATIONAL BUILDING CODE (IBC) AND THE 2014 CALIFORNIA BUILDING CODE (CBC).

3. ALL WORK SHALL BE IN ACCORDANCE WITH THE 2014 INTERNATIONAL MECHANICAL AND PLUMBING CODE (IMC) AND THE 2014 CALIFORNIA MECHANICAL AND PLUMBING CODE (CMPC).

LEGEND:

— CONDUIT

○ ELECTRICAL FIXTURE

□ ELECTRICAL PANEL

SCALE:

1" = 10'-0"

PROJECT LOCATION:

19th FLOOR

PROJECT OWNER:

[Name]

PROJECT MANAGER:

[Name]

PROJECT ENGINEER:

[Name]

PROJECT ARCHITECT:

[Name]

PROJECT CONSULTANT:

[Name]

PROJECT CONTRACTOR:

[Name]

PROJECT SUBCONTRACTOR:

[Name]

PROJECT VENDOR:

[Name]

PROJECT SUPPLIER:

[Name]

PROJECT DISTRIBUTOR:

[Name]

PROJECT INSTALLER:

[Name]

PROJECT MAINTENANCE:

[Name]

PROJECT OPERATOR:

[Name]

PROJECT REVIEWER:

[Name]

PROJECT APPROVER:

[Name]

PROJECT SIGNATURE:

[Signature]

PROJECT STAMP:

[Stamp]

PROJECT LOGO:

[Logo]

PROJECT CONTACT:

[Contact Information]

PROJECT WEBSITE:

[Website]

PROJECT PHONE:

[Phone Number]

PROJECT FAX:

[Fax Number]

PROJECT EMAIL:

[Email Address]

PROJECT ADDRESS:

[Address]

PROJECT CITY:

[City]

PROJECT STATE:

[State]

PROJECT ZIP:

[ZIP Code]

PROJECT COUNTRY:

[Country]

PROJECT REGION:

[Region]

PROJECT ZONE:

[Zone]

PROJECT DISTRICT:

[District]

PROJECT WARD:

[Ward]

PROJECT PARISH:

[Parish]

PROJECT TOWNSHIP:

[Township]

PROJECT COUNTY:

[County]

PROJECT DEPARTMENT:

[Department]

PROJECT DIVISION:

[Division]

PROJECT SECTION:

[Section]

PROJECT SUBSECTION:

[Subsection]

PROJECT UNIT:

[Unit]

PROJECT SUBUNIT:

[Subunit]

PROJECT EQUIPMENT:

[Equipment]

PROJECT COMPONENT:

[Component]

PROJECT PART:

[Part]

PROJECT MATERIAL:

[Material]

PROJECT FINISH:

[Finish]

PROJECT COLOR:

[Color]

PROJECT PATTERN:

[Pattern]

PROJECT TEXTURE:

[Texture]

PROJECT GLASS:

[Glass]

PROJECT METAL:

[Metal]

PROJECT WOOD:

[Wood]

PROJECT STONE:

[Stone]

PROJECT CERAMIC:

[Ceramic]

PROJECT TILE:

[Tile]

PROJECT CARPET:

[Carpet]

PROJECT FLOOR:

[Floor]

PROJECT WALL:

[Wall]

PROJECT CEILING:

[Ceiling]

PROJECT DOOR:

[Door]

PROJECT WINDOW:

[Window]

PROJECT STAIR:

[Stair]

PROJECT ELEVATOR:

[Elevator]

PROJECT ESCALATOR:

[Escalator]

PROJECT RAMP:

[Ramp]

PROJECT DRIVEWAY:

[Driveway]

PROJECT PARKING:

[Parking]

PROJECT LOT:

[Lot]

PROJECT TRAIL:

[Trail]

PROJECT ROAD:

[Road]

PROJECT HIGHWAY:

[Highway]

PROJECT BRIDGE:

[Bridge]

PROJECT TUNNEL:

[Tunnel]

PROJECT UNDERPASS:

[Underpass]

PROJECT OVERPASS:

[Overpass]

PROJECT INTERCHANGE:

[Interchange]

PROJECT JUNCTION:

[Junction]

PROJECT ROUNDABOUT:

[Roundabout]

PROJECT SIGNAL:

[Signal]

PROJECT LIGHT:

[Light]

PROJECT SIGN:

[Sign]

PROJECT MARKER:

[Marker]

PROJECT REFLECTOR:

[Reflector]

PROJECT BARRIER:

[Barrier]

PROJECT FENCE:

[Fence]

PROJECT GATE:

[Gate]

PROJECT WALL:

[Wall]

PROJECT DOOR:

[Door]

PROJECT WINDOW:

[Window]

PROJECT STAIR:

[Stair]

PROJECT ELEVATOR:


[Elevator]


PROJECT ESCALATOR:


[Escalator]

PROJECT RAMP:


[Ramp]

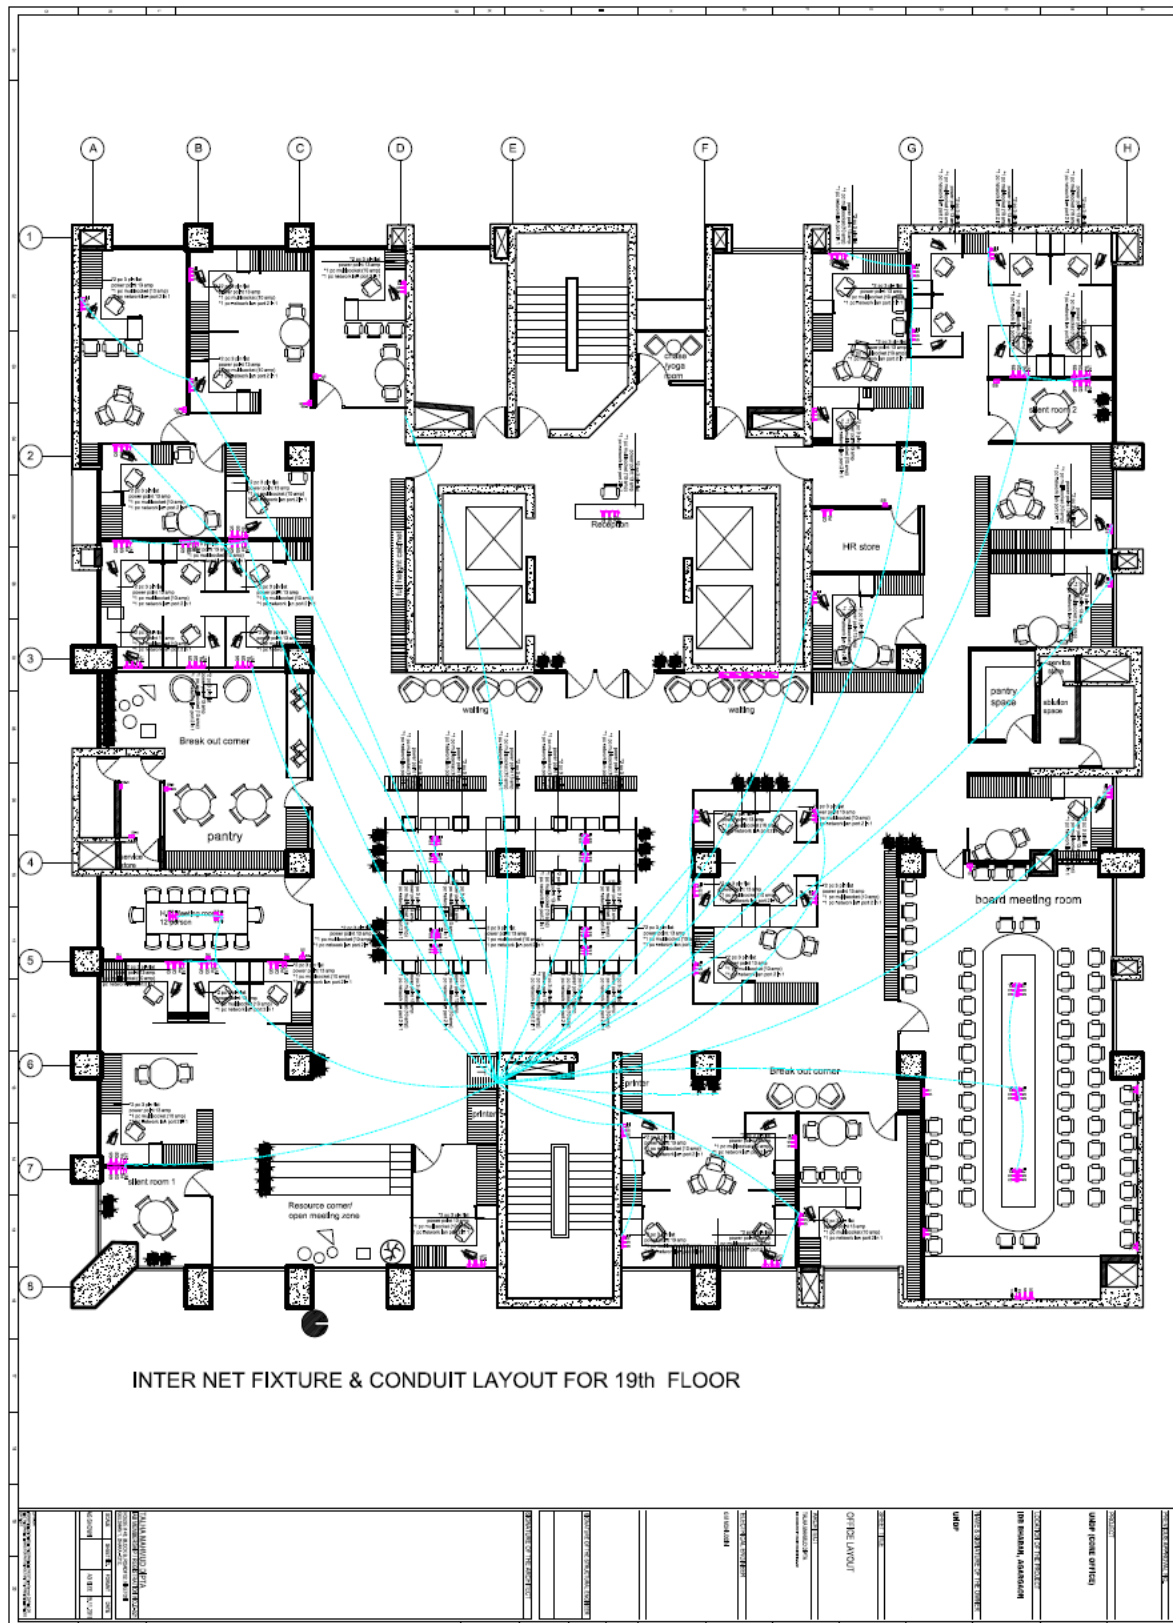

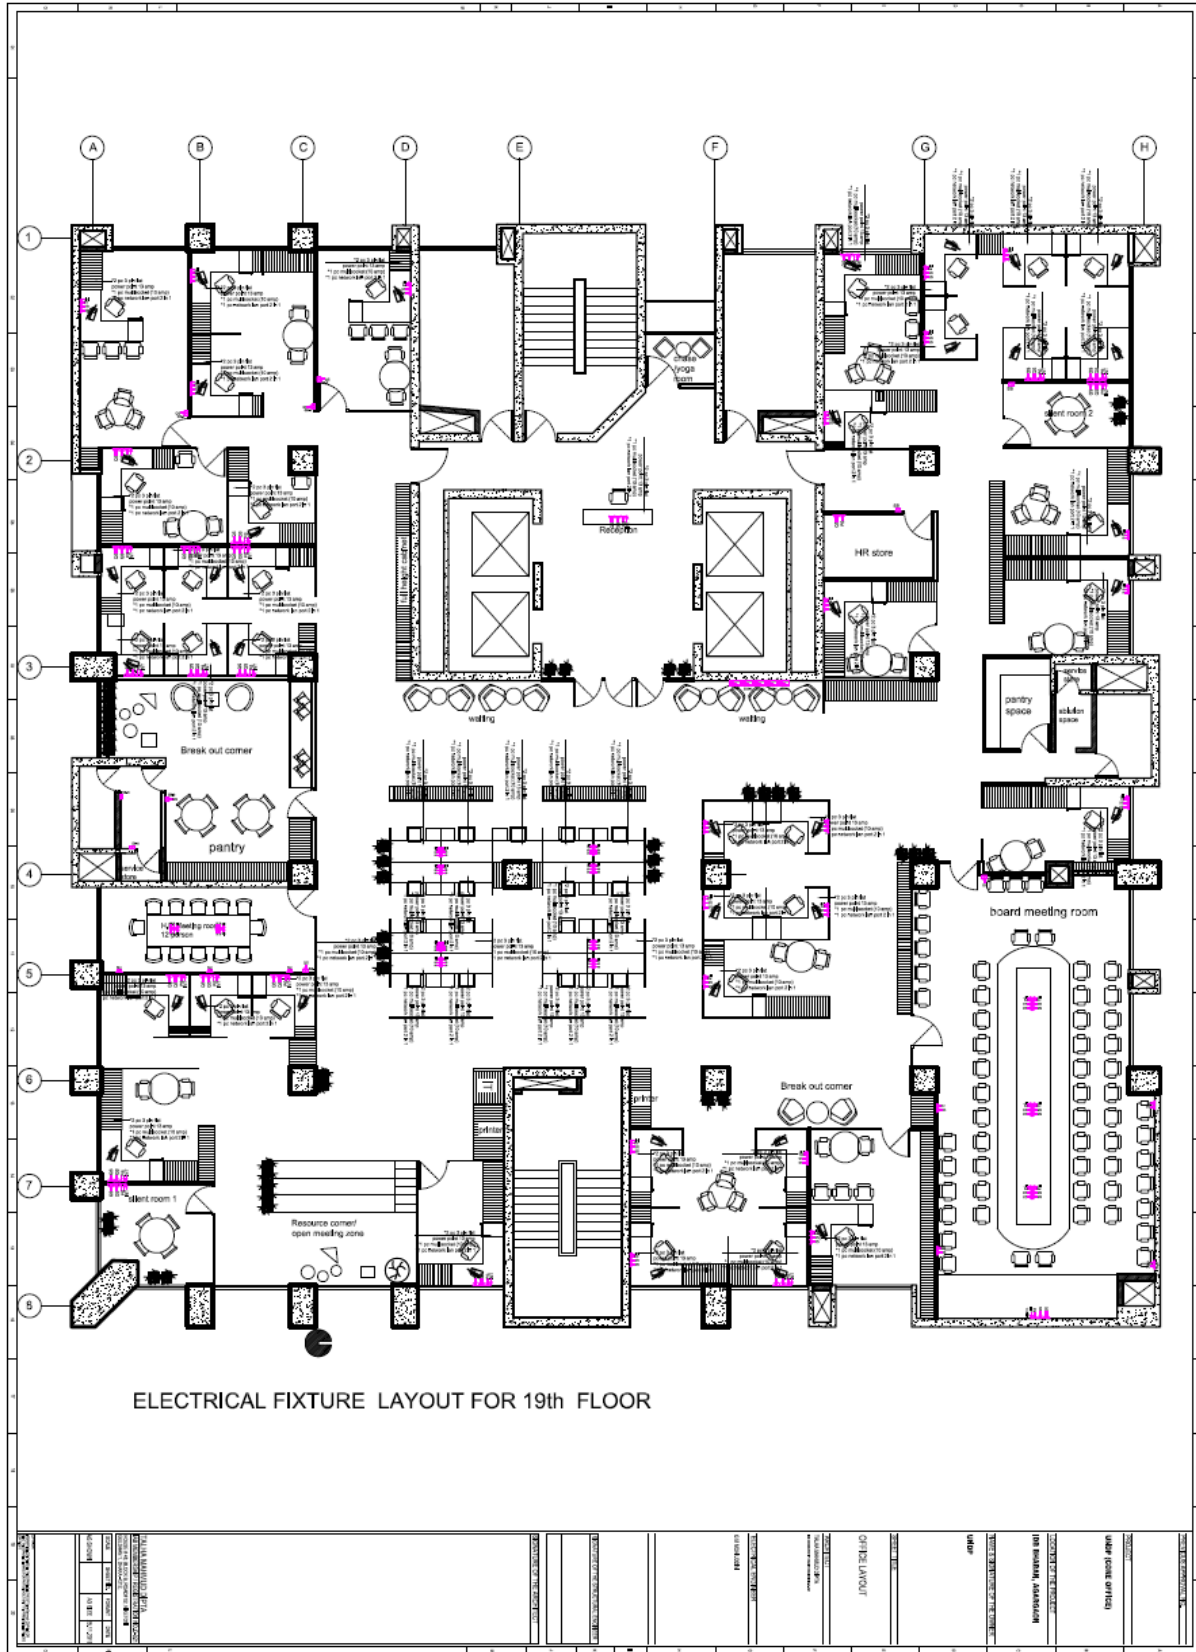

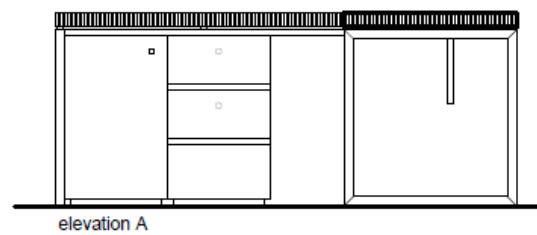

workstation (type-2)

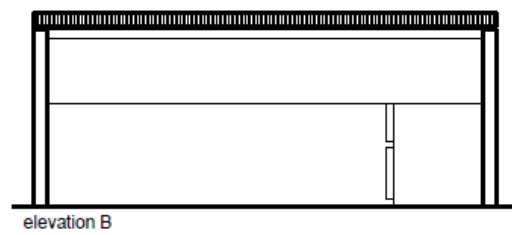

elevation B

TAL HA MAHMUD DIFTA			
JAL MAHARUDDIN, KANDAMBA, KEMAS, KEMAS			
KANDAMBA, KANDAMBA, KANDAMBA, KANDAMBA			
KANDAMBA, KANDAMBA, KANDAMBA, KANDAMBA			
NAME	DATE	TIME	DATE
JAL MAHARUDDIN		12:00	12:00

