





Amendment-1c-to Annex-4-RFQ-BD-2019-027 (Drawing)

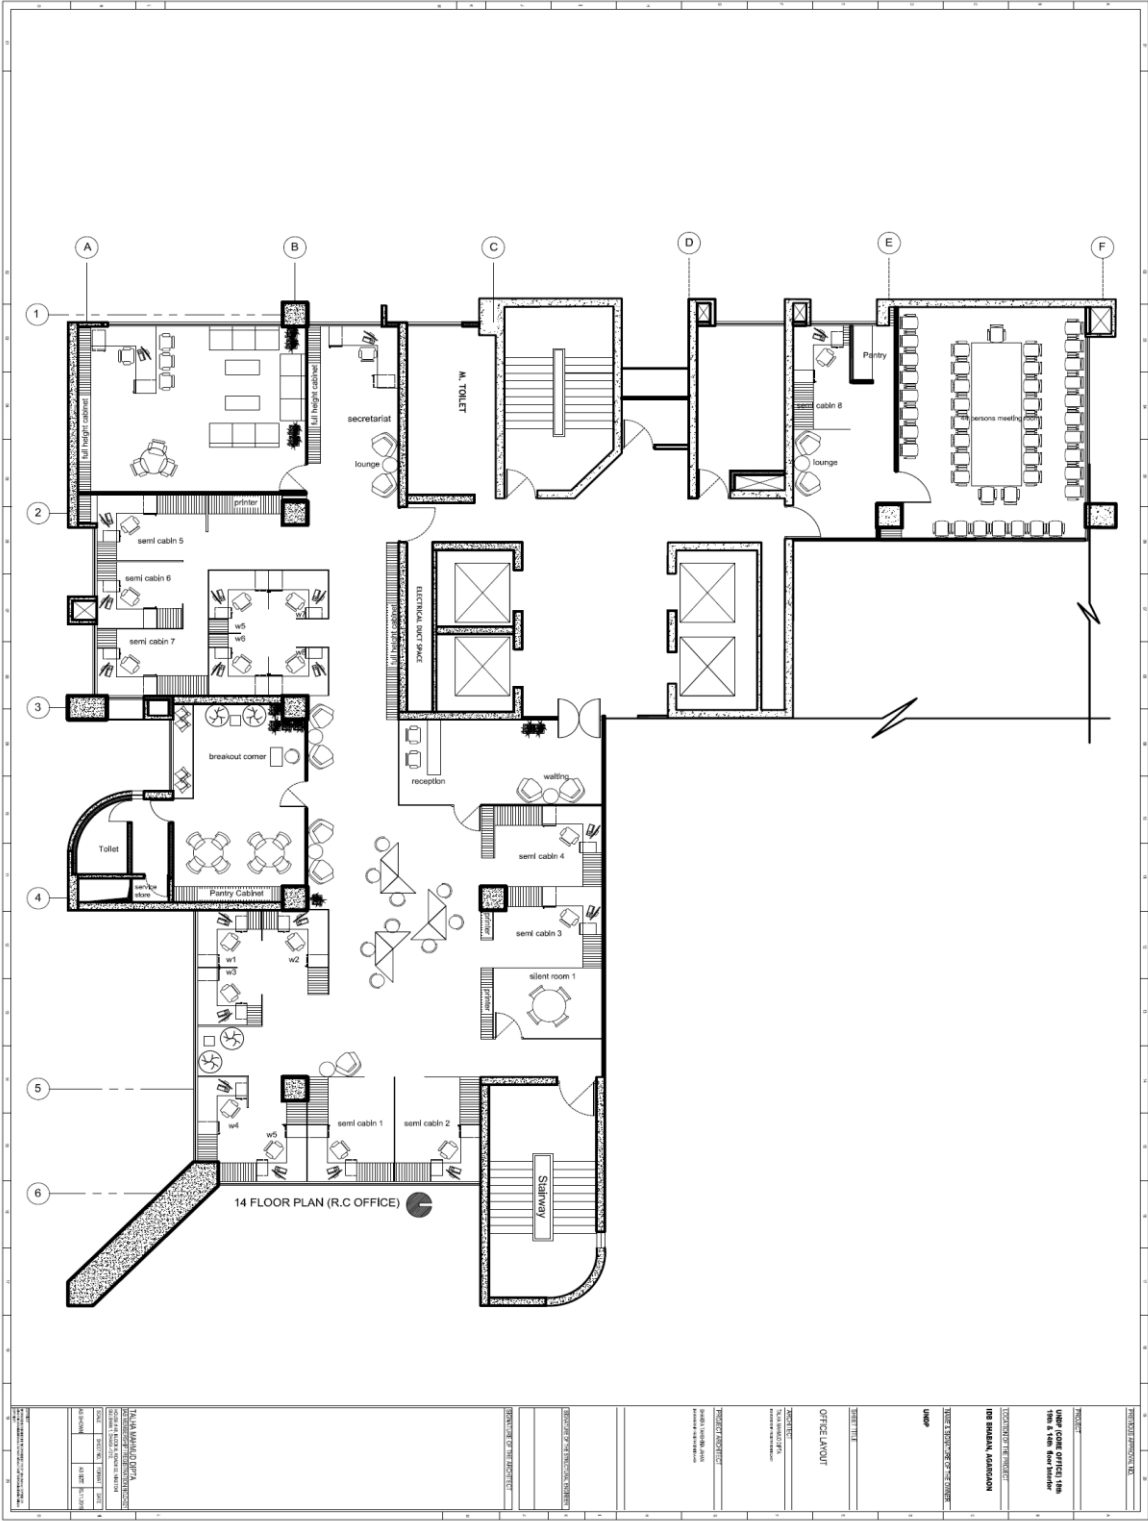


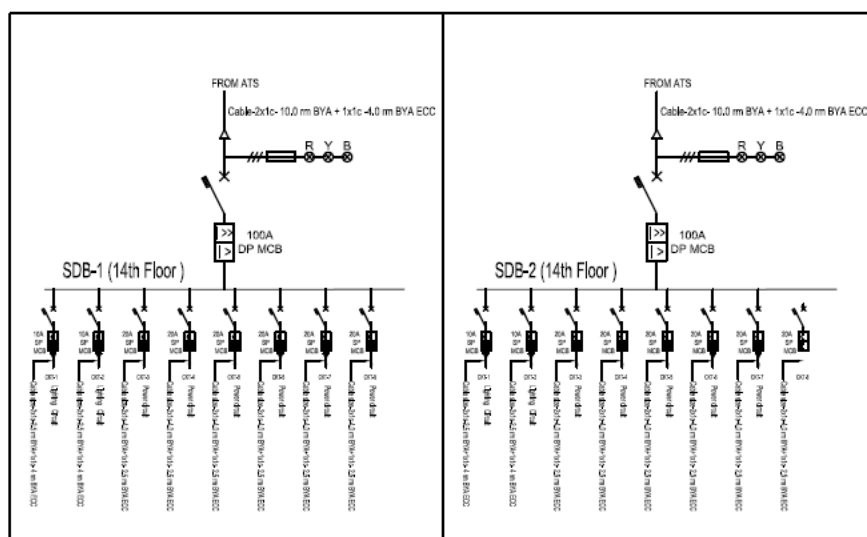

ELECTRICAL CIRCUIT DIAGRAM (SINGLE LINE DIAGRAM)

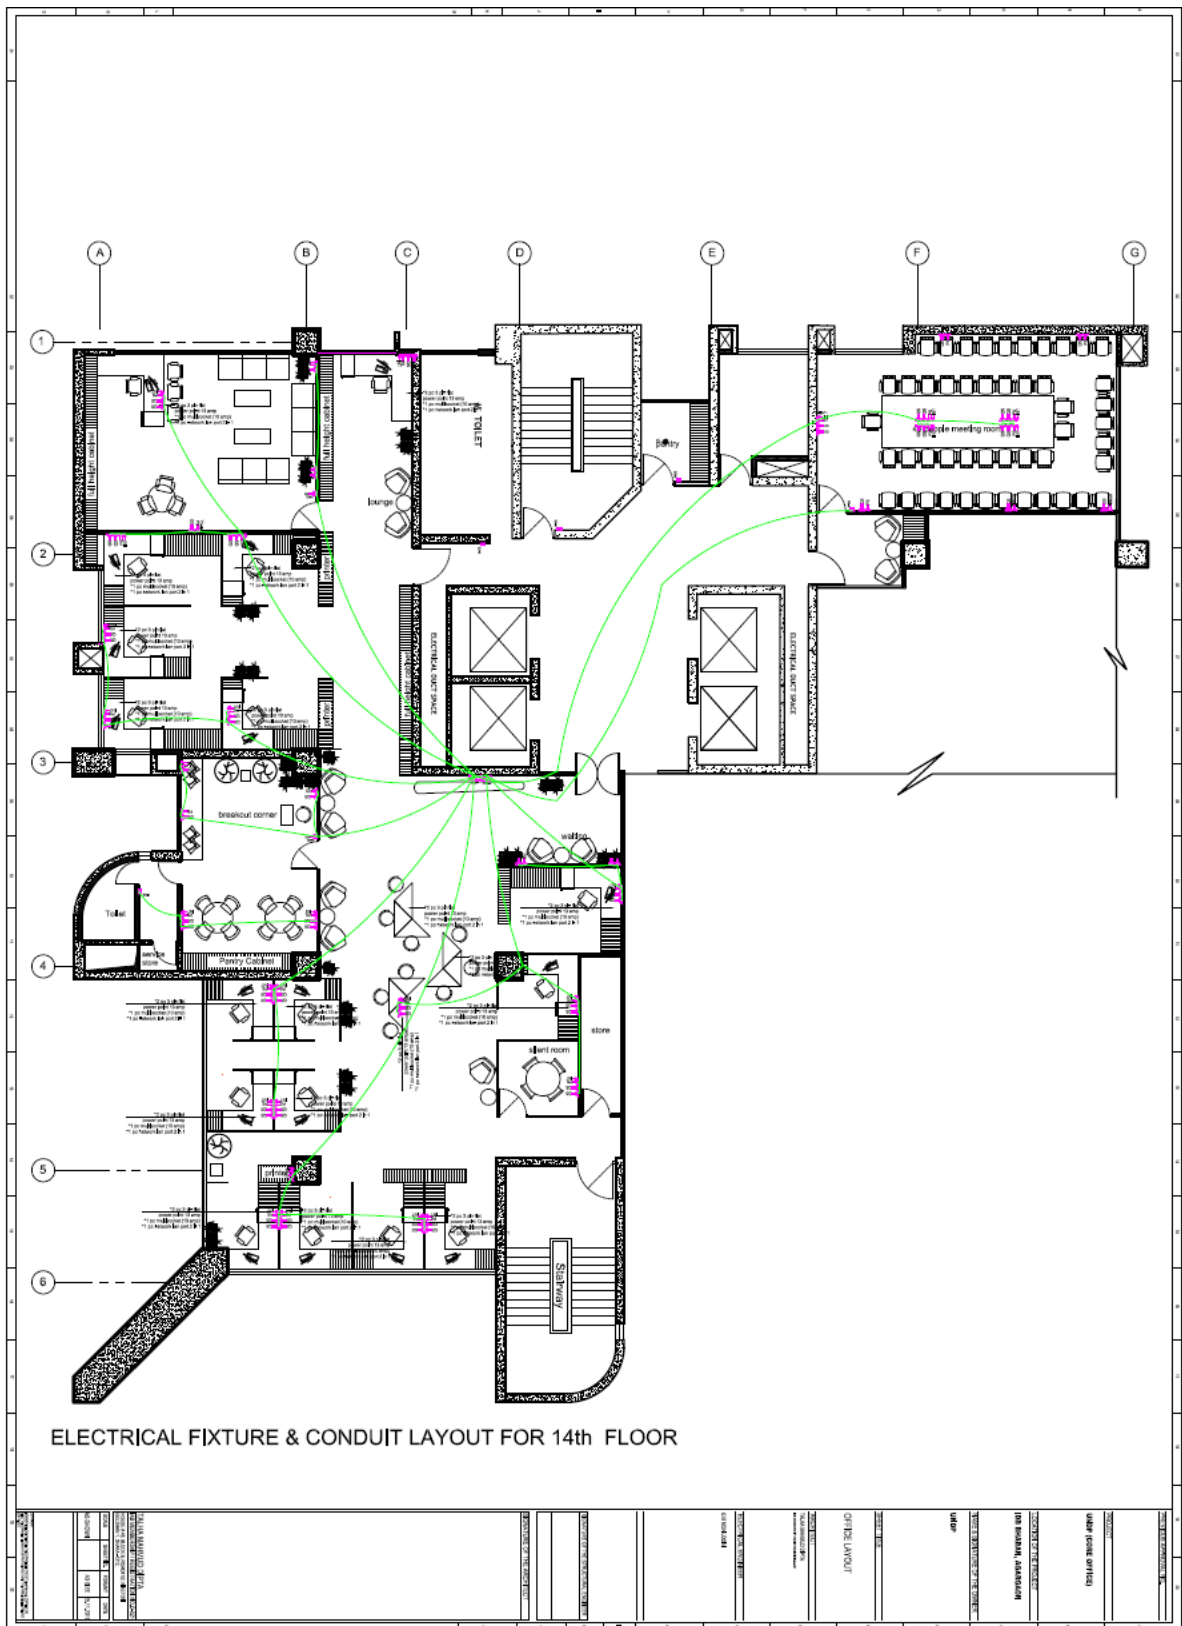

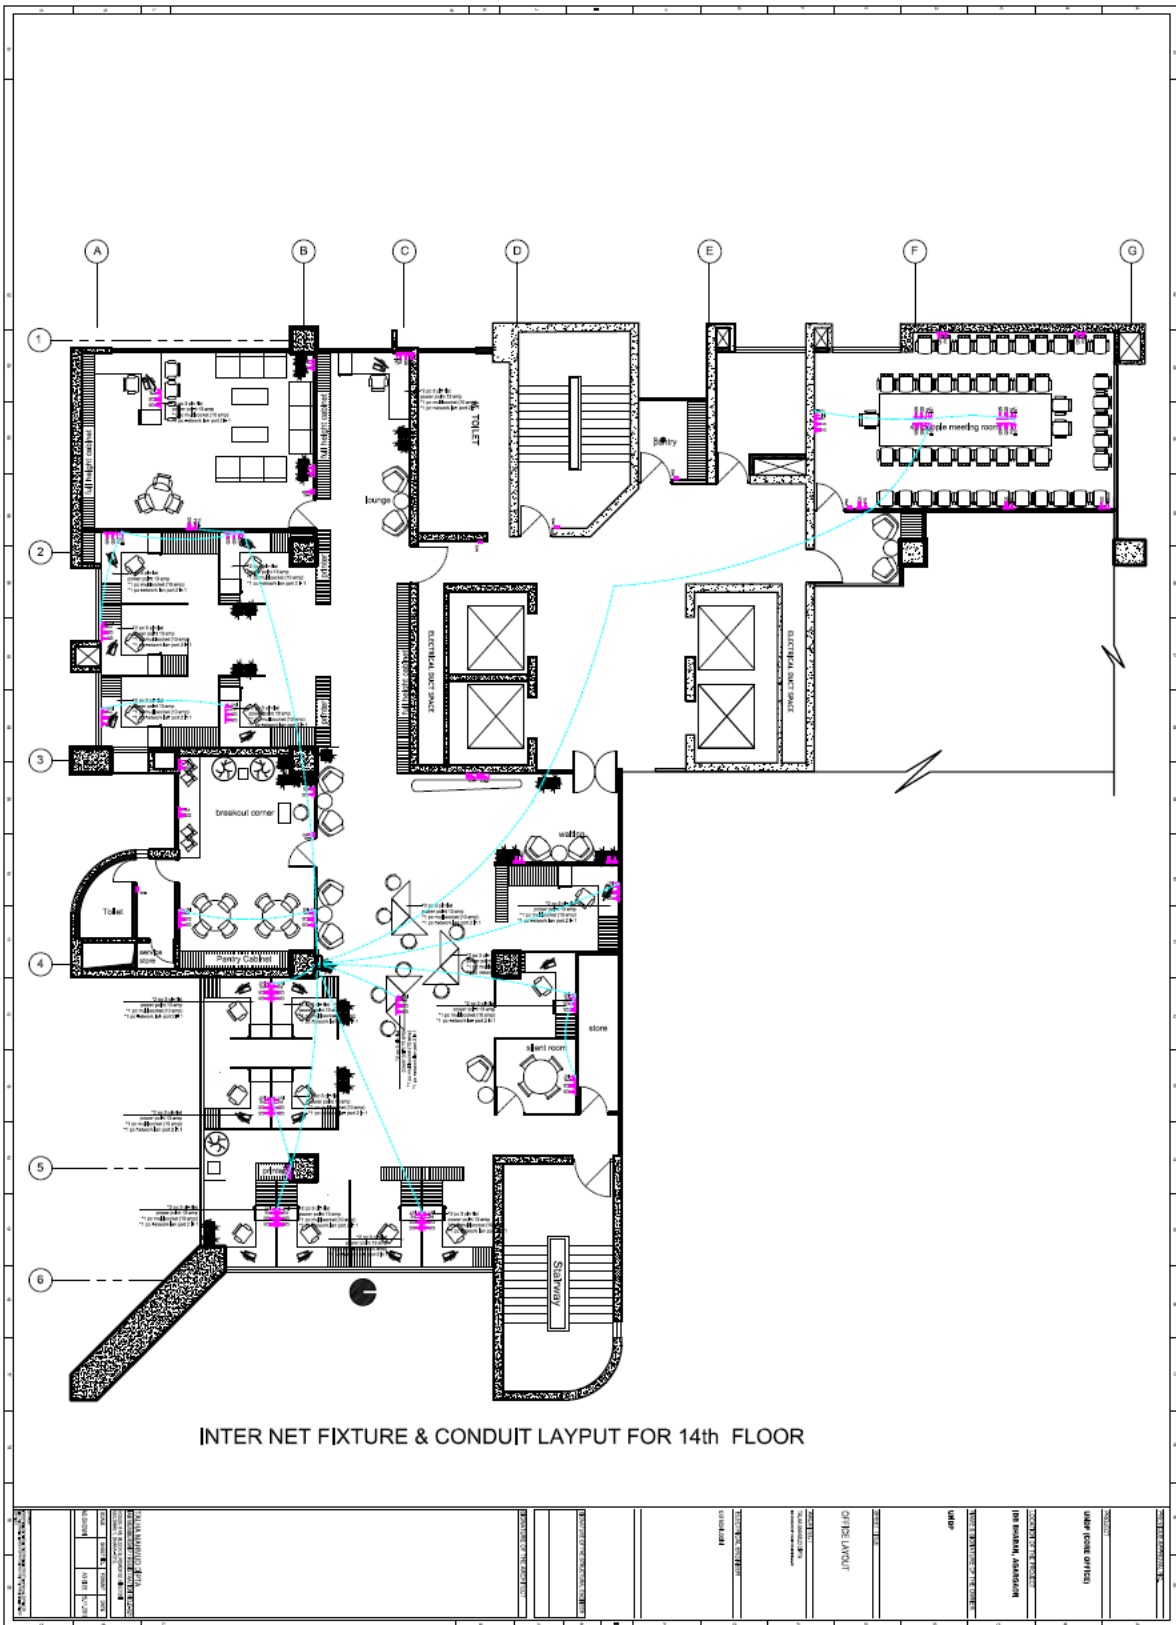

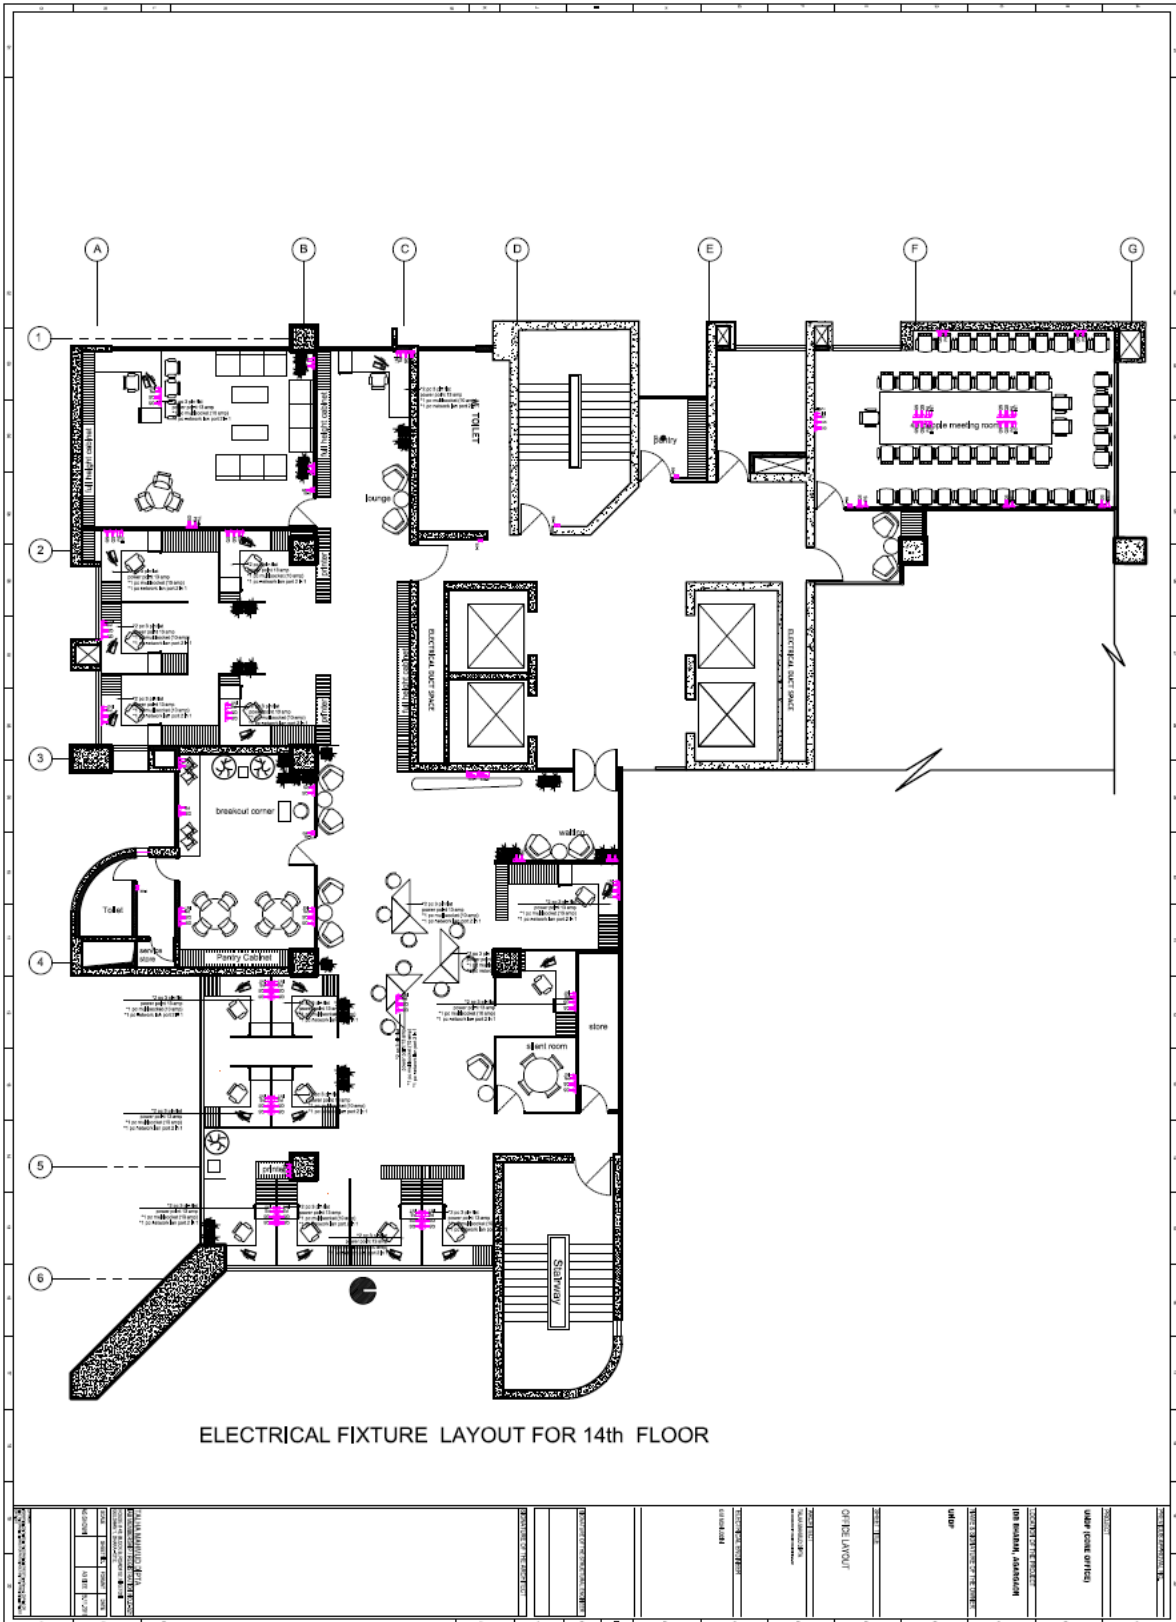

DATE: 10/10/2018	PROJECT: 14th FLOOR RENOVATION	DESIGNER: [REDACTED]	CHECKED: [REDACTED]	APPROVED: [REDACTED]
SCALE: 1/8" = 1'-0"	NOTES: SEE ELECTRICAL SPECIFICATIONS	REVISIONS: 1. REVISED LAYOUT	DATE: 10/10/2018	BY: [REDACTED]
ELECTRICAL LAYOUT				
1. ALL ELECTRICAL WORK SHALL BE IN ACCORDANCE WITH THE 2017 NATIONAL ELECTRICAL CODE (NEC) AND THE 2018 CALIFORNIA ELECTRICAL CODE (CEC).				
2. ALL ELECTRICAL WORK SHALL BE DONE BY A LICENSED ELECTRICIAN.				
3. ALL ELECTRICAL WORK SHALL BE DONE IN ACCORDANCE WITH THE 2017 NATIONAL ELECTRICAL CODE (NEC) AND THE 2018 CALIFORNIA ELECTRICAL CODE (CEC).				
4. ALL ELECTRICAL WORK SHALL BE DONE IN ACCORDANCE WITH THE 2017 NATIONAL ELECTRICAL CODE (NEC) AND THE 2018 CALIFORNIA ELECTRICAL CODE (CEC).				
5. ALL ELECTRICAL WORK SHALL BE DONE IN ACCORDANCE WITH THE 2017 NATIONAL ELECTRICAL CODE (NEC) AND THE 2018 CALIFORNIA ELECTRICAL CODE (CEC).				
6. ALL ELECTRICAL WORK SHALL BE DONE IN ACCORDANCE WITH THE 2017 NATIONAL ELECTRICAL CODE (NEC) AND THE 2018 CALIFORNIA ELECTRICAL CODE (CEC).				

