


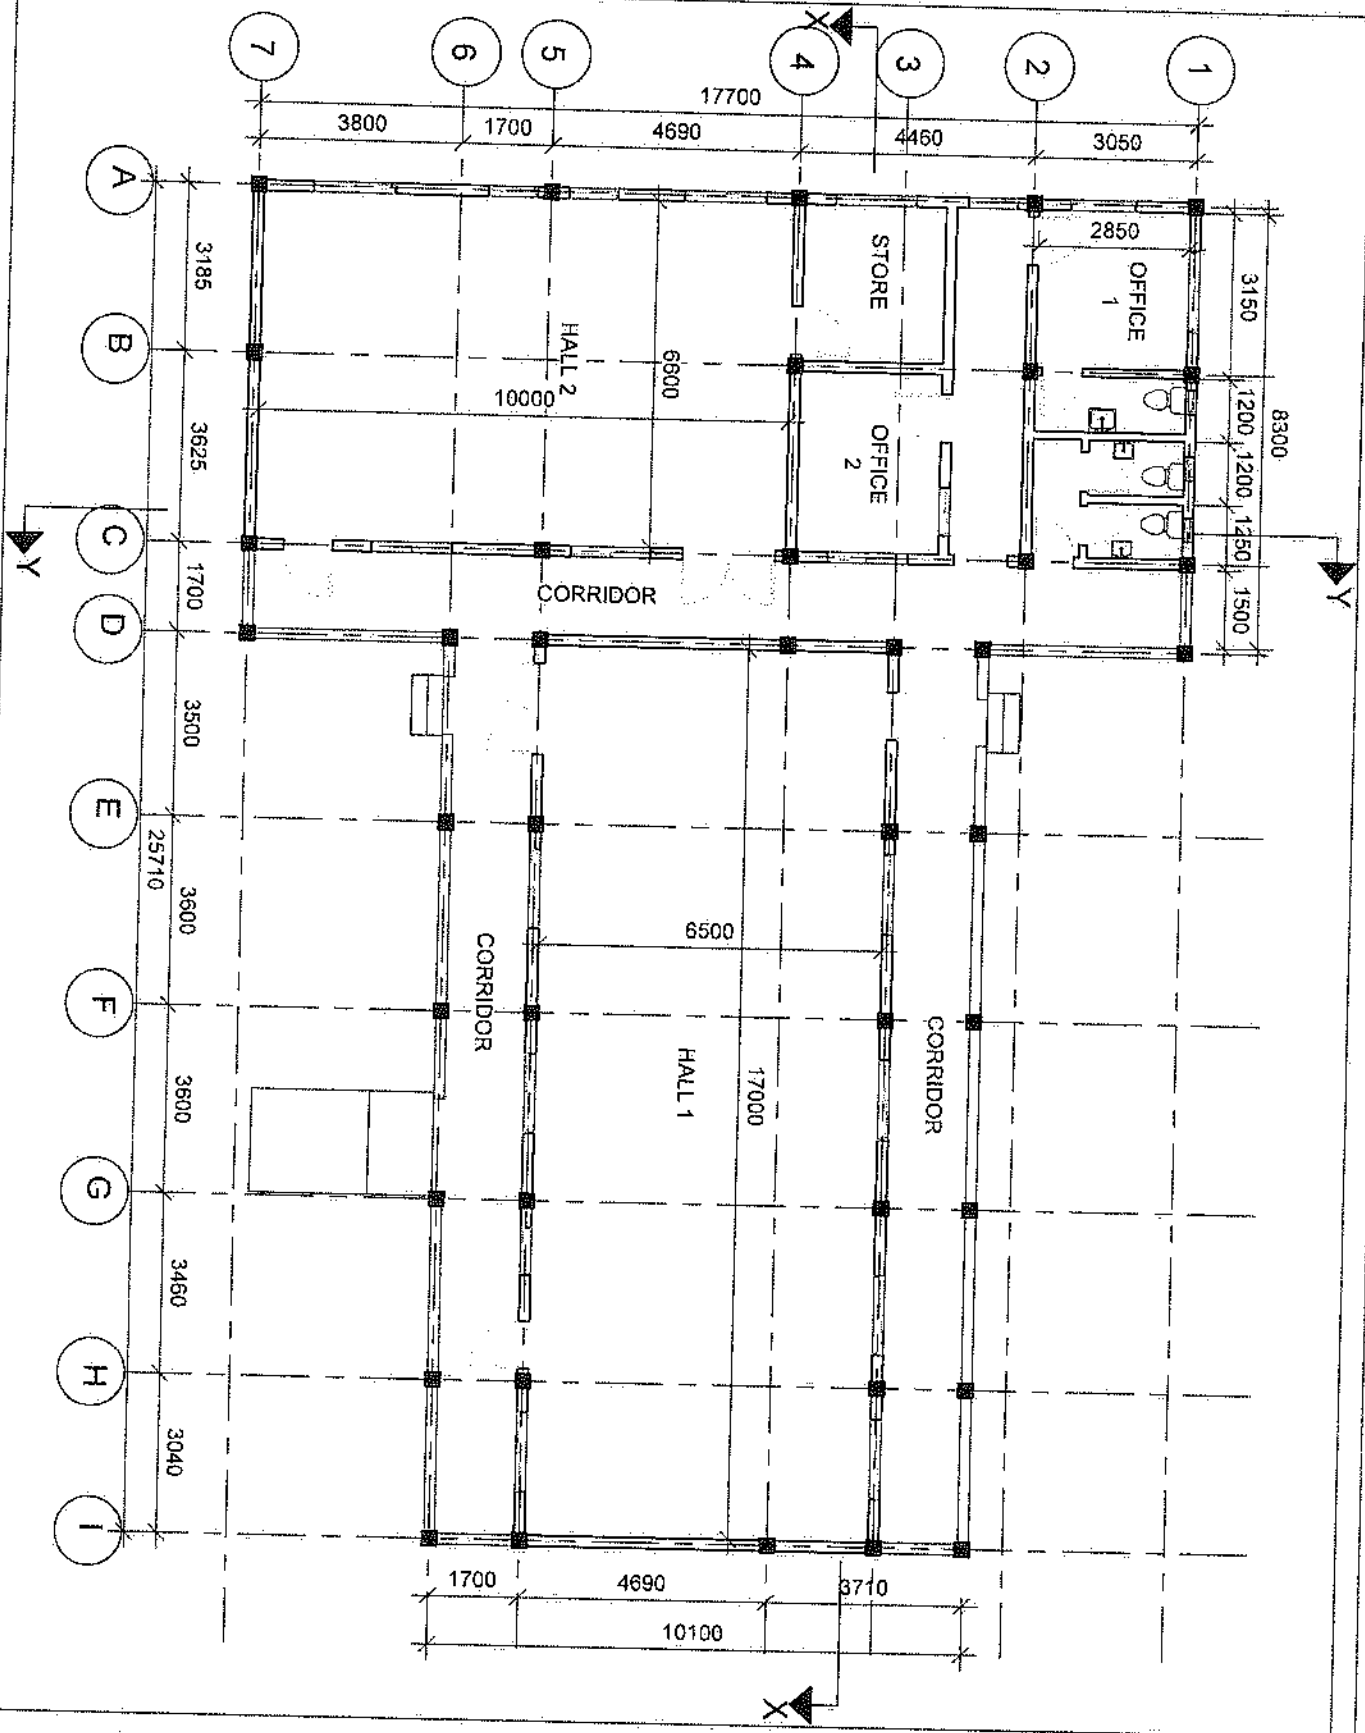

NOTE

1. All work shall be in accordance with the latest edition of the relevant codes and standards.
2. The design is based on the information provided by the client and is not to be used for any other purpose without the written consent of the consultant.
3. All work shall be completed by the date specified in the contract.

DESIGN CONSULTANT

By: **Mr. A. H. Hossain**

Technical and Architectural Design
Engineering and Construction Services

Project No.: **100/2023/01**
Drawing No.: **100/2023/01/01**

PROJECT

**PROPOSED CONSTRUCTION
OF YOUTH CONNECT HUB**

Location

**HONGOR BENDJAU
PALAWA DISTRICT**

CLIENT

UNDP

**DRAWING
DESCRIPTION**

GROUND FLOOR PLAN

Scale: 1:100

Date: JULY 2023

Drawing Number	Revision
P01	

NOTE	
1. All work shall include a 25% profit margin.	
2. All work shall include a 10% profit margin.	
3. All work shall include a 5% profit margin.	

DESIGN CONSULTANT	
Ing. S. J. R. R. R.	
Technical and Architectural Design	
Engineering and Construction	
Project No.	10000000000000000000
Project Name	10000000000000000000
Project Location	10000000000000000000

PROJECT	
PROPOSED CONSTRUCTION OF YOUTH CORNER HUB	
Project No.	10000000000000000000
Project Name	10000000000000000000
Project Location	10000000000000000000

LOCATION	
MOUNGON BENDU, FLORIDA DISTRICT	


CLIENT	
UNDP	

DRAWING DESCRIPTION	
FRONT VIEW	

Scale: 1:100	
--------------	--

Date:	JULY 2020
-------	-----------

Drawing Number	10000000000000000000
Page	10000000000000000000

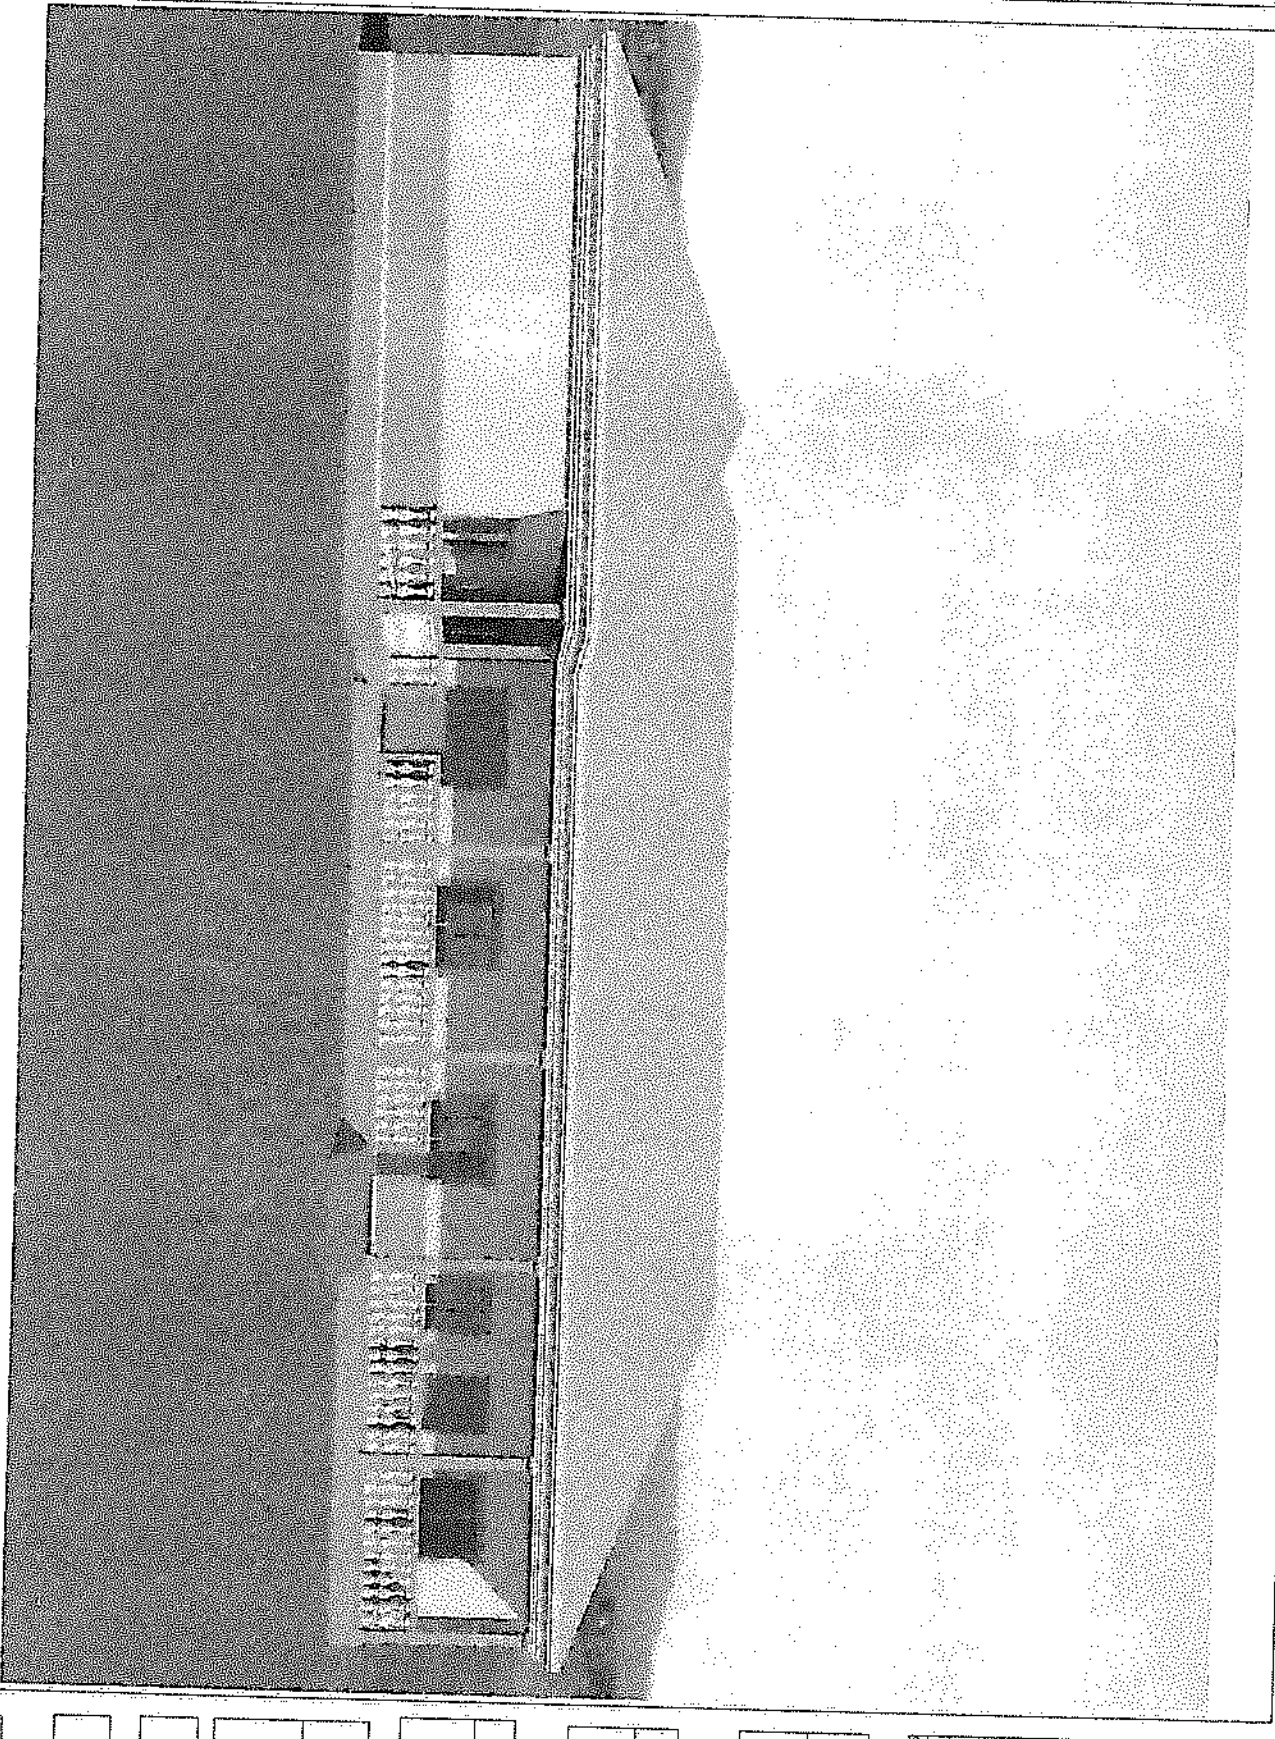

1. All blocks under this sign are 12' x 12' x 12' and are made of concrete.
 2. Color of concrete must match the color of the blocks.
 3. All blocks must be made of concrete.

DESIGN CONSULTANT

By: **Dr. J. N. Smith**
 Title: **Principal and Architectural Designer**
 Firm: **Smith & Associates, Inc.**
 Address: **1234 Main Street, Suite 100, Anytown, CA 90210**
 Phone: **(555) 123-4567**
 Email: **info@smithandassociates.com**

PROJECT

PROPOSED CONSTRUCTION OF YOUTH CONNECT HUB

Location
MORGAN BENDISU
PALM BEACH DISTRICT


CLIENT
UNDP

DRAWING DESCRIPTION
RIGHT VIEW

Scale 1:100

Date JULY 2020

Drawing Number P-05

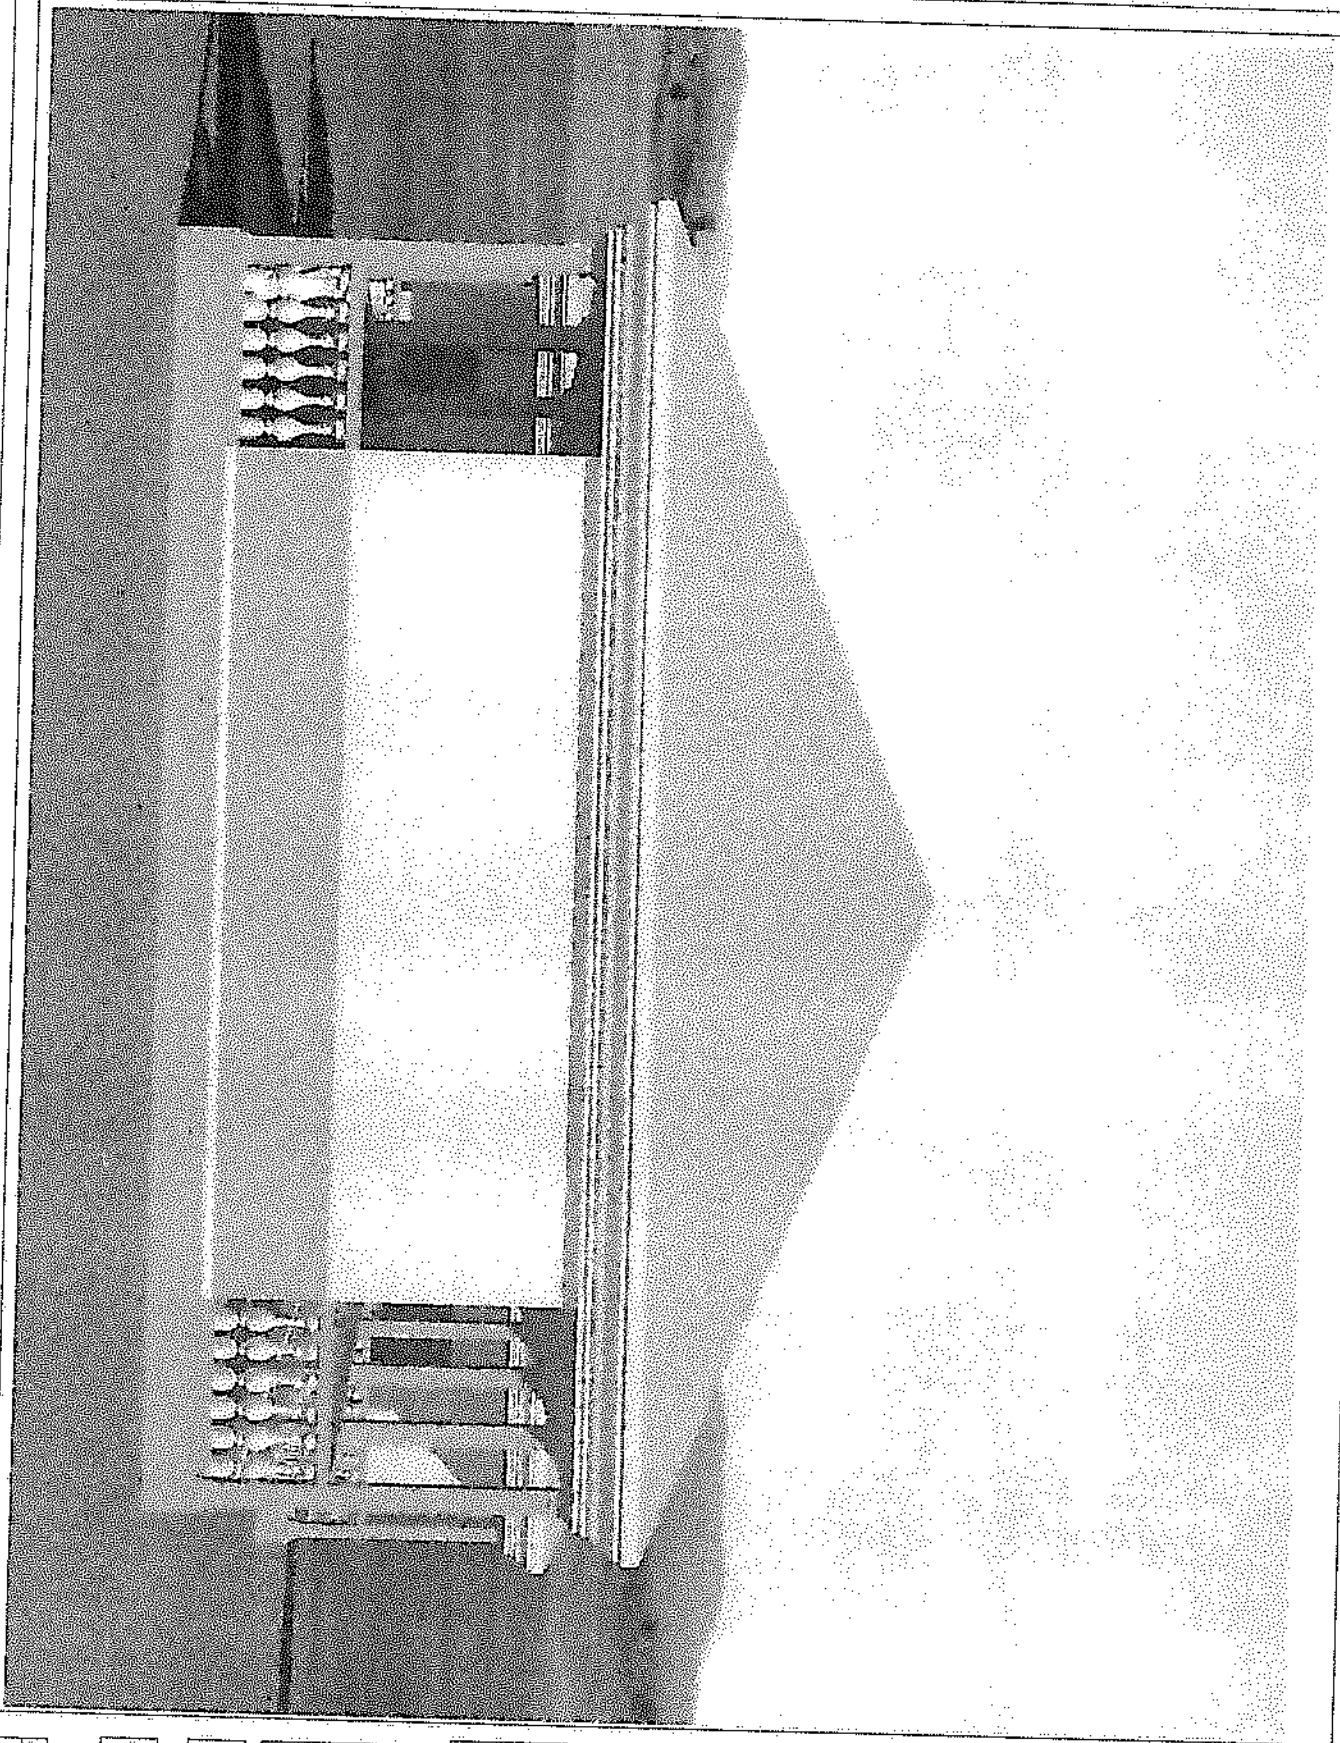

1. Aerial view of the building at 250m scale.
2. Ground level view of the building at 100m scale.
3. Aerial view of the building at 250m scale.

DESIGN CONSULTANT

Mr. S. S. S. S.	
Technical and Architectural design	Engineered/Architect/Structural
Drawn by:	Mr. S. S. S. S.
Checked by:	Mr. S. S. S. S.

PROJECT

PROPOSED CONSTRUCTION OF 10000 CONNECTION M&B

Location

HONOR BENDUQU PALAYA DISTRICT

CLIENT

UNDP


TRAINING DESCRIPTION


REAR VIEW

Scale: 1:100

Date: JULY 2020

Drawing Number:	Revision:
P07	

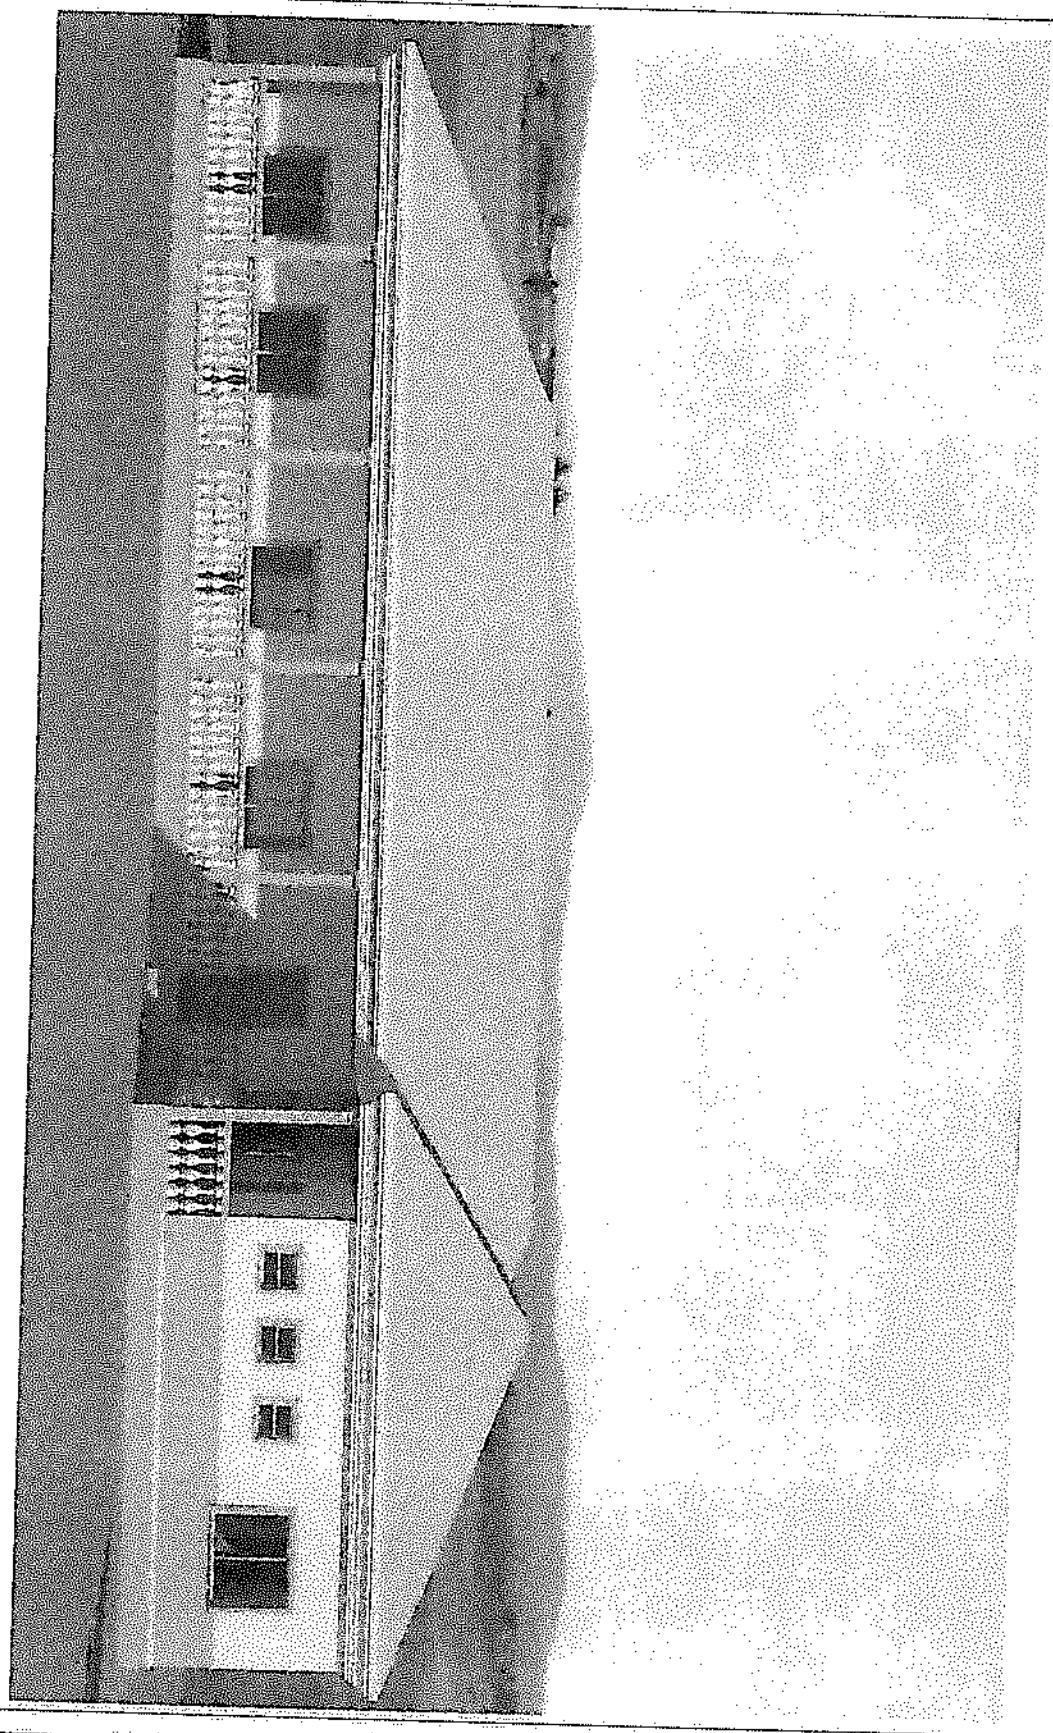

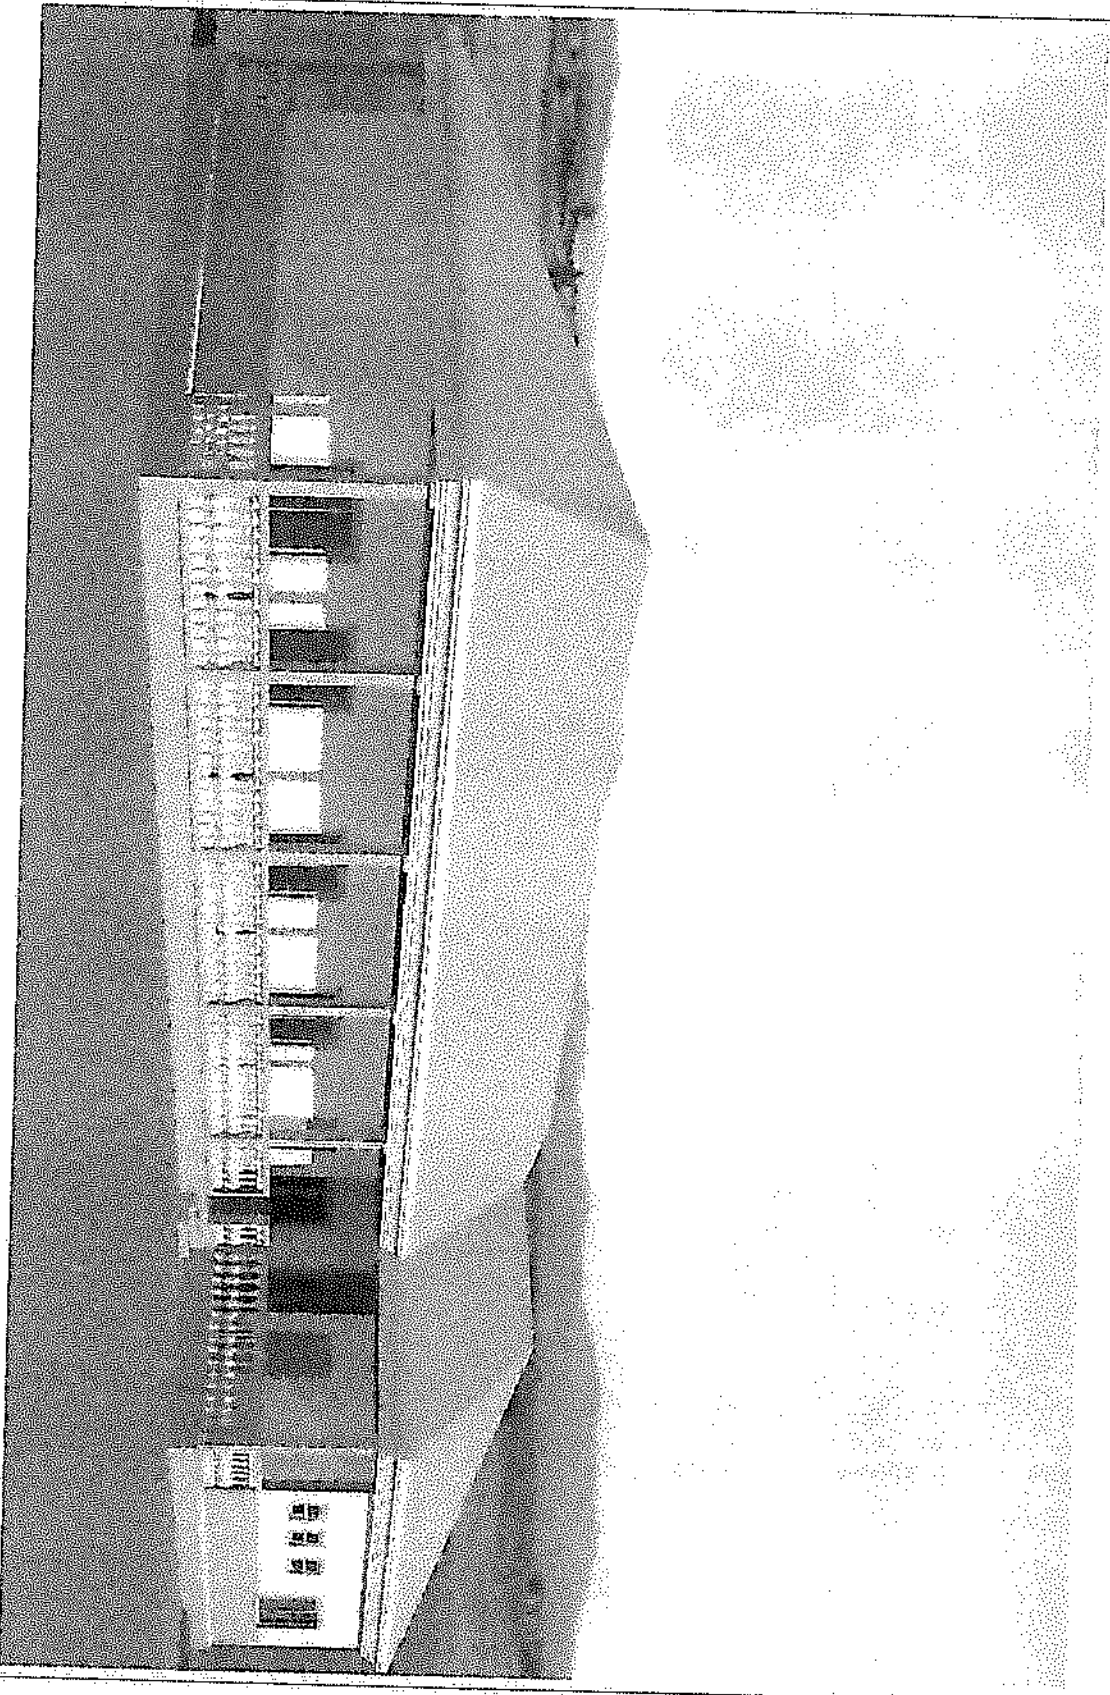

1. All drawings shall be prepared in accordance with the standards of the International Standards Organization (ISO) and the American National Standards Institute (ANSI).
 2. All drawings shall be prepared in accordance with the standards of the International Standards Organization (ISO) and the American National Standards Institute (ANSI).
 3. All drawings shall be prepared in accordance with the standards of the International Standards Organization (ISO) and the American National Standards Institute (ANSI).

DESIGN CONSULTANT

Mr. John A. Smith
 President and Managing Director
 Engineering & Construction
 1234 Main Street
 Suite 500
 Anytown, CA 90210

PROJECT

PROPOSED CONSTRUCTION
 OF YOUTH CENTER IN B

Location

MONSIEUR REYNOL
 PALM BEACH DISTRICT

CLIENT

UNDP

DRAWING DESCRIPTION

PERSPECTIVE VIEW 2

Scale


1:100

Date

JULY 2020

Drawing Number	Revision
POA	

Drawing Number	Revision
P10	

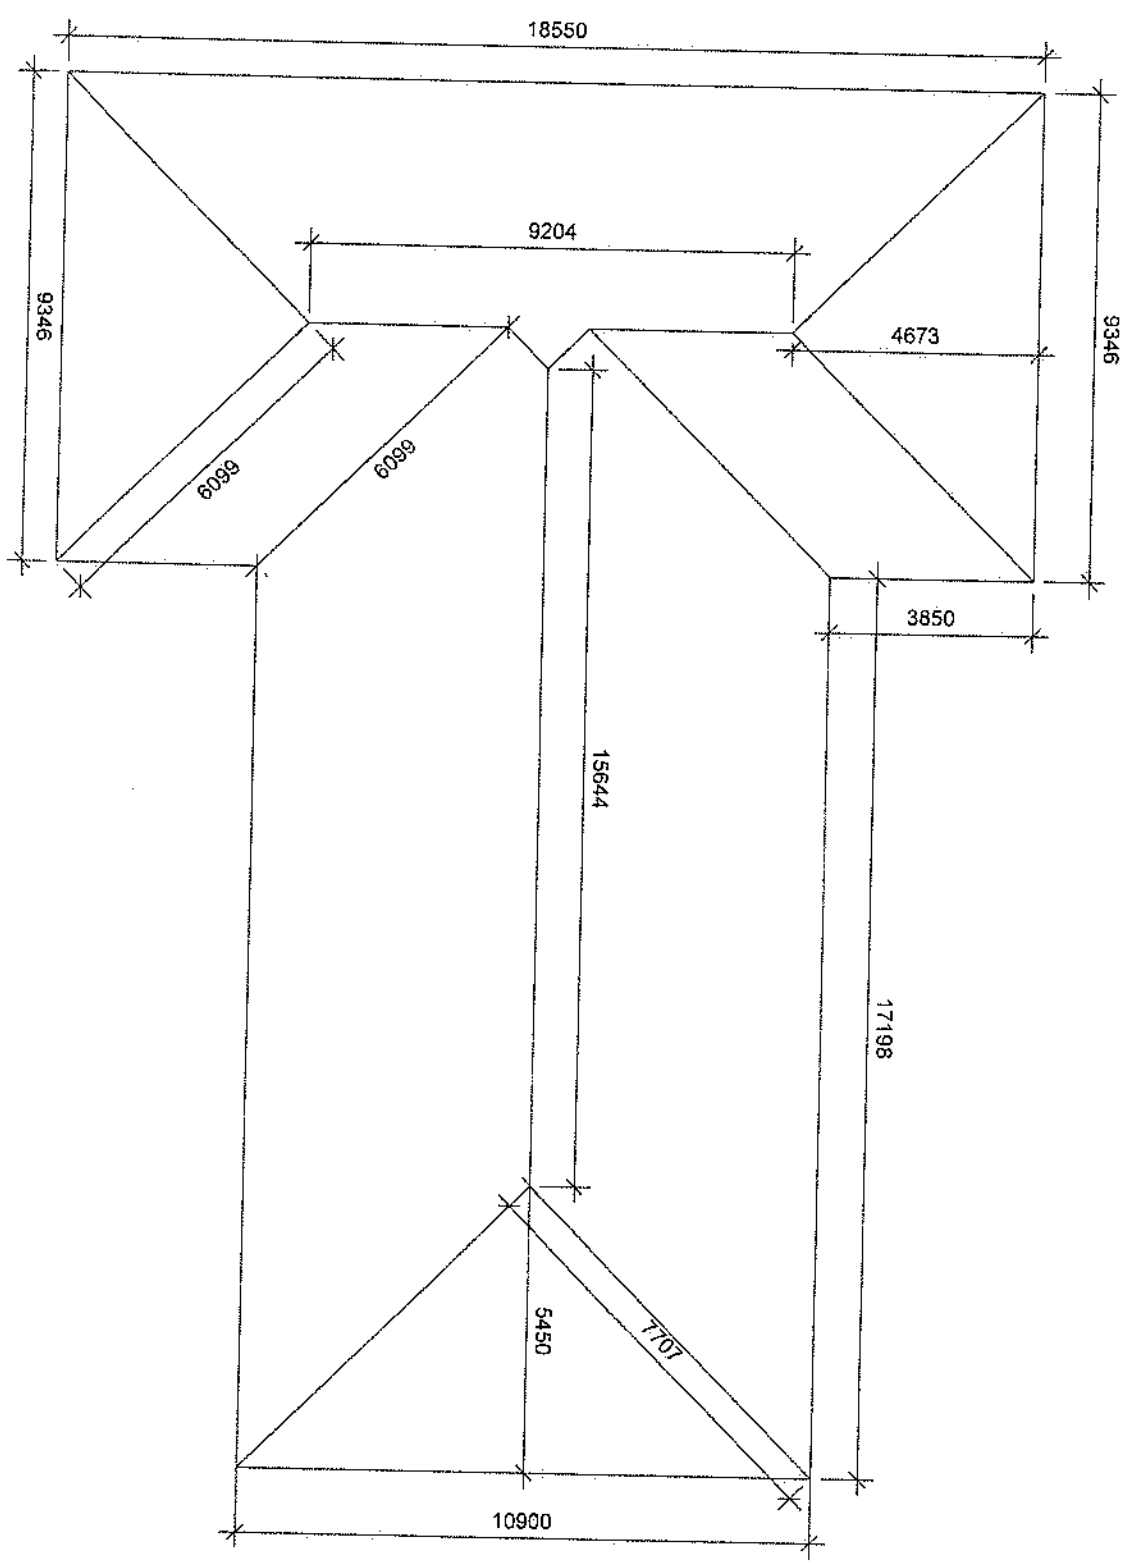

NOTE

1. All work shall conform to 25mm
2. All work shall conform to 25mm
3. All work shall conform to 25mm

DESIGN CONSULTANT

Ing. Saeed A. N. Fawzi

Technical and Architectural Design

Engineering and Architecture

Design No. Ing. Saeed A. N. Fawzi

Project No. Ing. Saeed A. N. Fawzi

PROJECT

PROPOSED CONSTRUCTION

OF YOUTH CONNECT HUB

Location

MONSIEUR BENJAMIN

PALMIRA DISTRICT

CLIENT

UNDP

DRAWING DESCRIPTION


ROOF PLAN

Scale: 1:100

Date: JULY 2020

Drawing Number: P10

Revision:

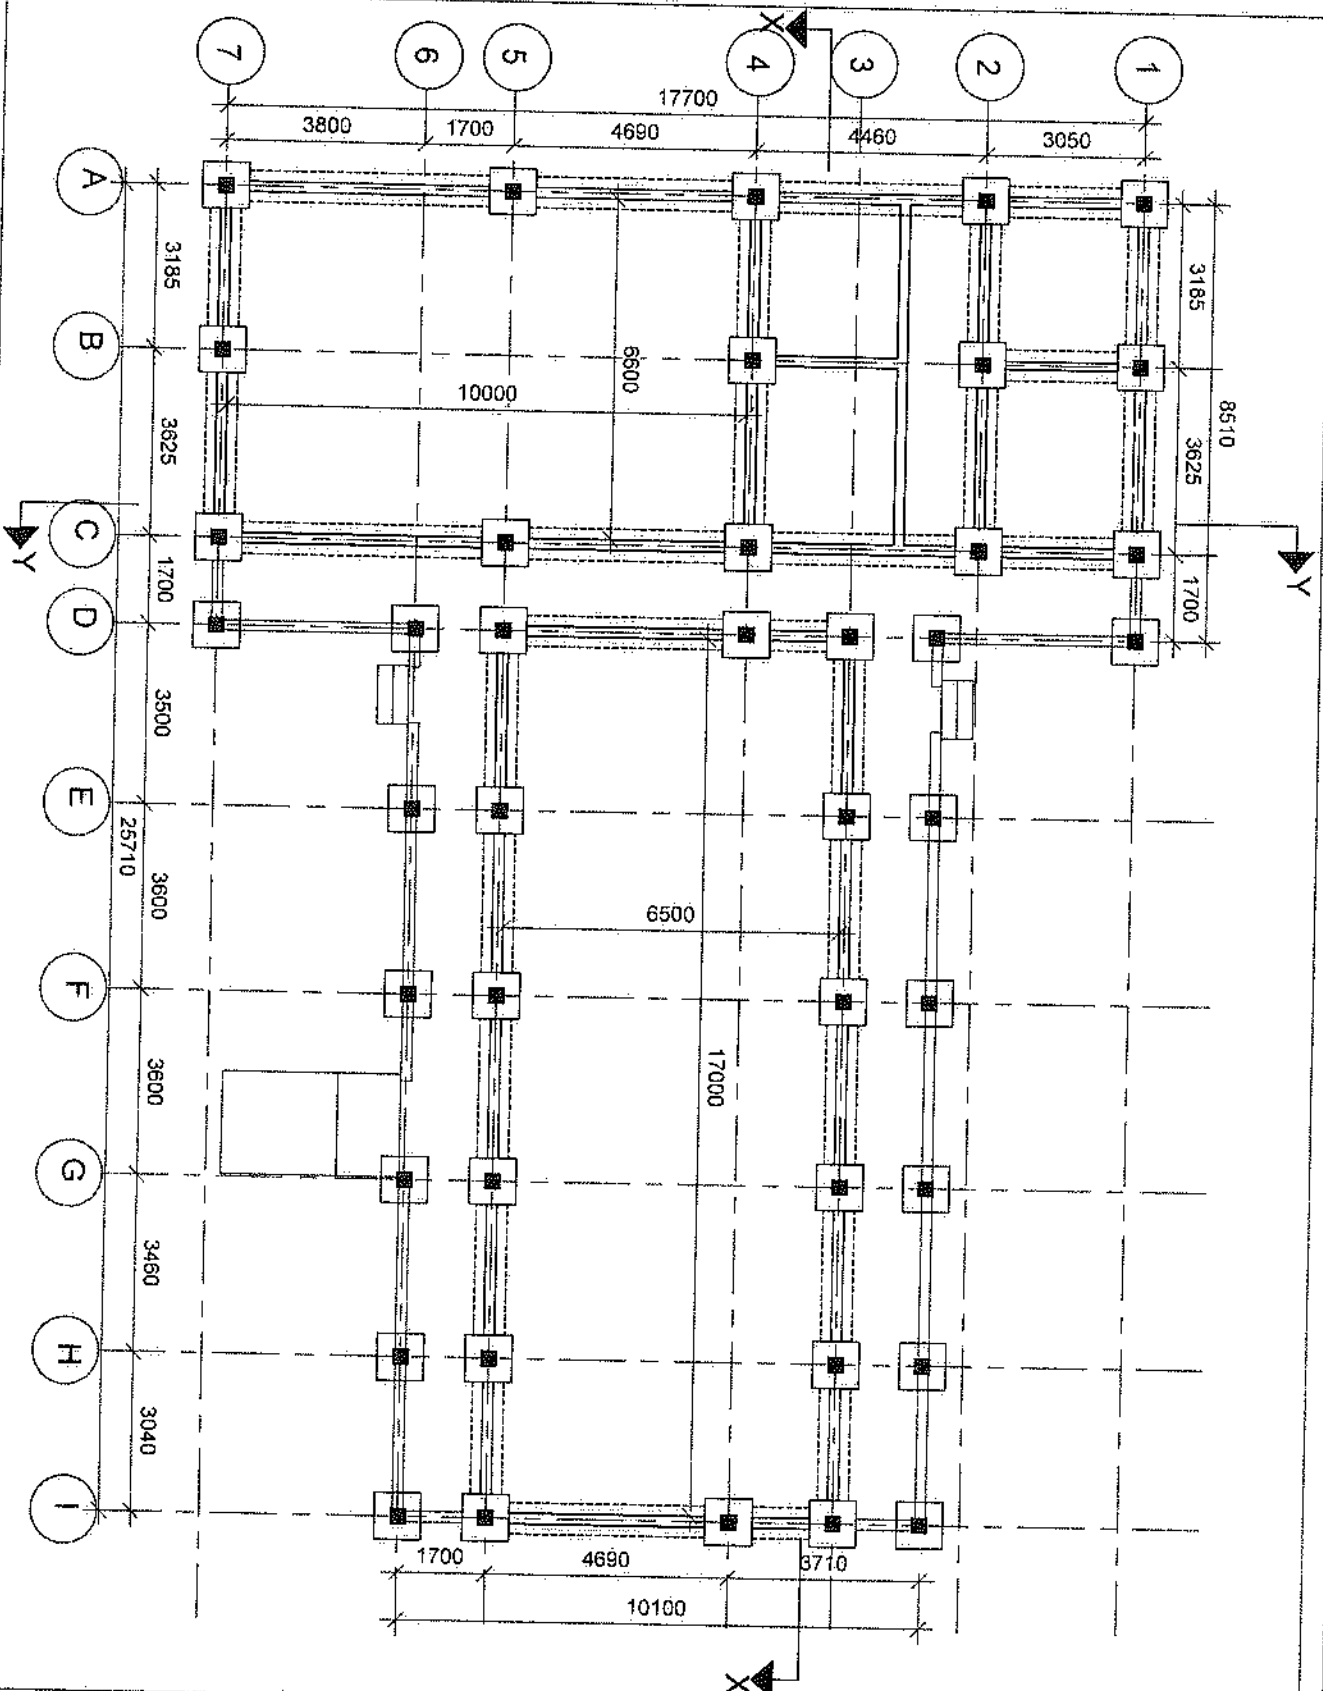

NOTE

1. All dimensions are in millimeters.
2. All dimensions are to the center of the column.
3. All dimensions are to the center of the beam.

DESIGN CONSULTANT

Eng. Saeed A. K. Al-Sayid
 Structural and Architectural Design
 Engineering and Construction
 Design Office
 Baghdad, Iraq

PROJECT

PROPOSED CONSTRUCTION
 OF YOUTH CENTER (R&B)

Location

MONSIEUR BEHAGU
 TALABA DISTRICT

CLIENT

UNOP

DRAWING DESCRIPTION

FOUNDATION PLAN

Scale: 1:100

Date: JULY 2020

Drawing Number	Revision
P11	

NOTE	
1. All work shall be in accordance with the latest edition of the relevant standards.	
2. All work shall be in accordance with the latest edition of the relevant standards.	
3. All work shall be in accordance with the latest edition of the relevant standards.	

DESIGN CONSULTANT	
Mr. S. S. S. S.	
Technical and Architectural Design	
Drawn by: Mr. S. S. S. S.	
Checked by: Mr. S. S. S. S.	

PROJECT	
PROPOSED CONSTRUCTION OF YOUTH CONNECT HUB	

Location	
MONGSON BENDUJOU PALMBA DISTRICT	





CLIENT	
UNDP	


DRAWING DESCRIPTION	
FOUNDATION DETAIL	

Scale: 1:100	
--------------	--

Date: JULY 2020	
-----------------	--

Drawing Number: P12	Version: 1
---------------------	------------

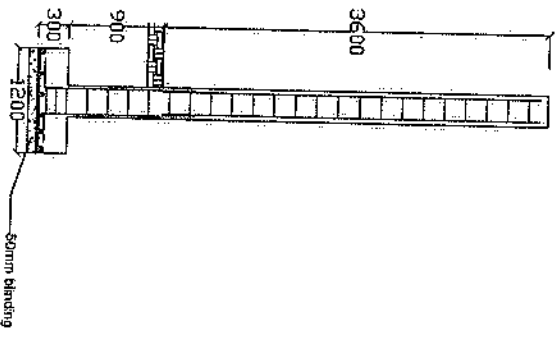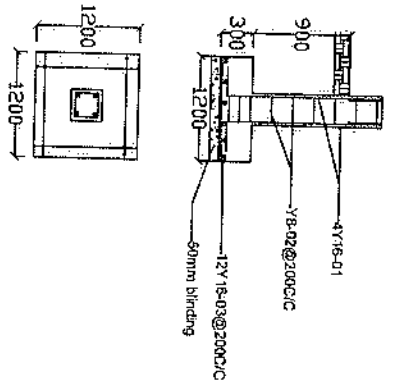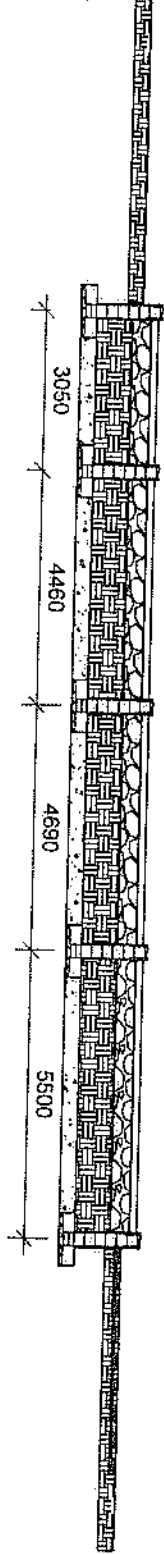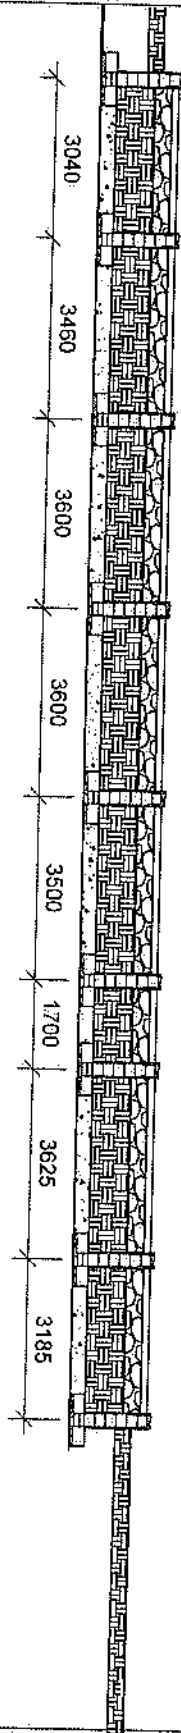

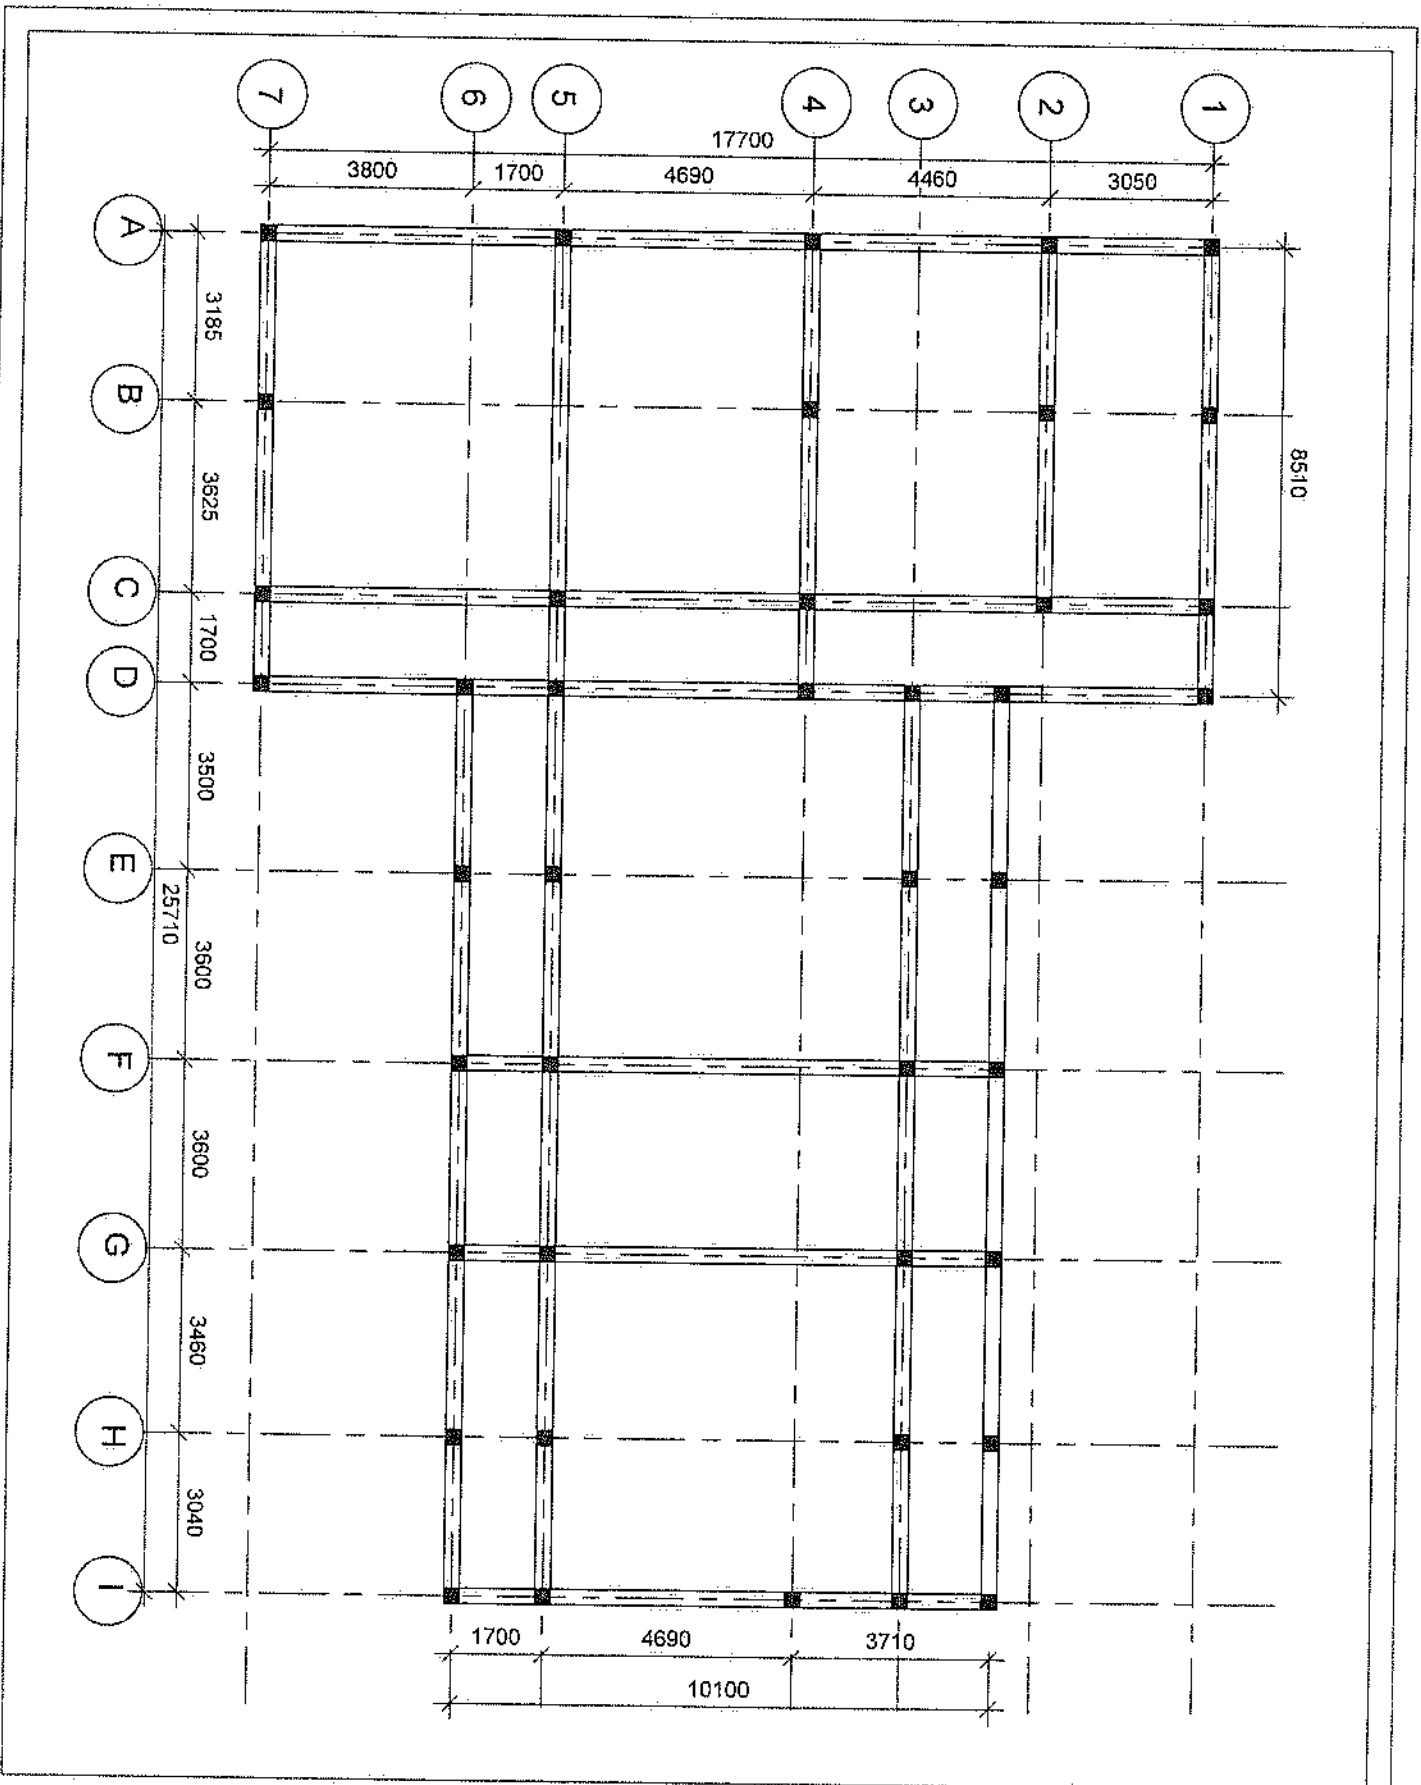

NOTE

1. All work shall conform to the 2015 International Building Code (IBC).
2. All work shall conform to the 2015 International Mechanical Code (IMC).
3. All work shall conform to the 2015 International Plumbing Code (IPC).

DESIGN CONSULTANT

by **SAE T. N. Hoang**
 Technical and Structural Design
 Engineering and Construction
 10/10/2020
 10/10/2020

PROJECT

PROPOSED CONSTRUCTION OF YOUTH CONNECT HUB

Location

MONSIEUR BENDJOU PALMIRA DISTRICT

CLIENT

UNDP


DRAWING DESCRIPTION

BEAM LAYOUT


Scale: 1:100

Date: JULY 2020

Drawing Number: **P13** Section: **Section**

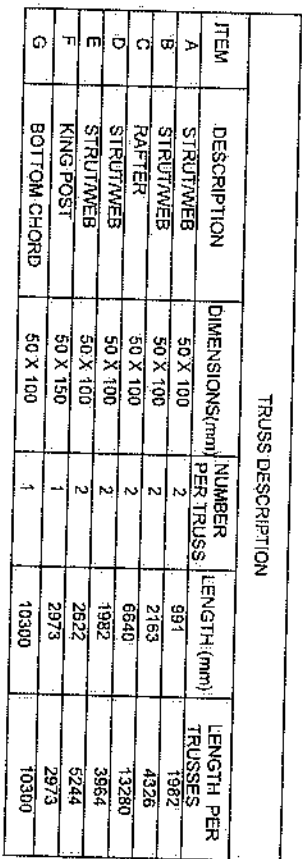

Drawing Number	Revision
P15	

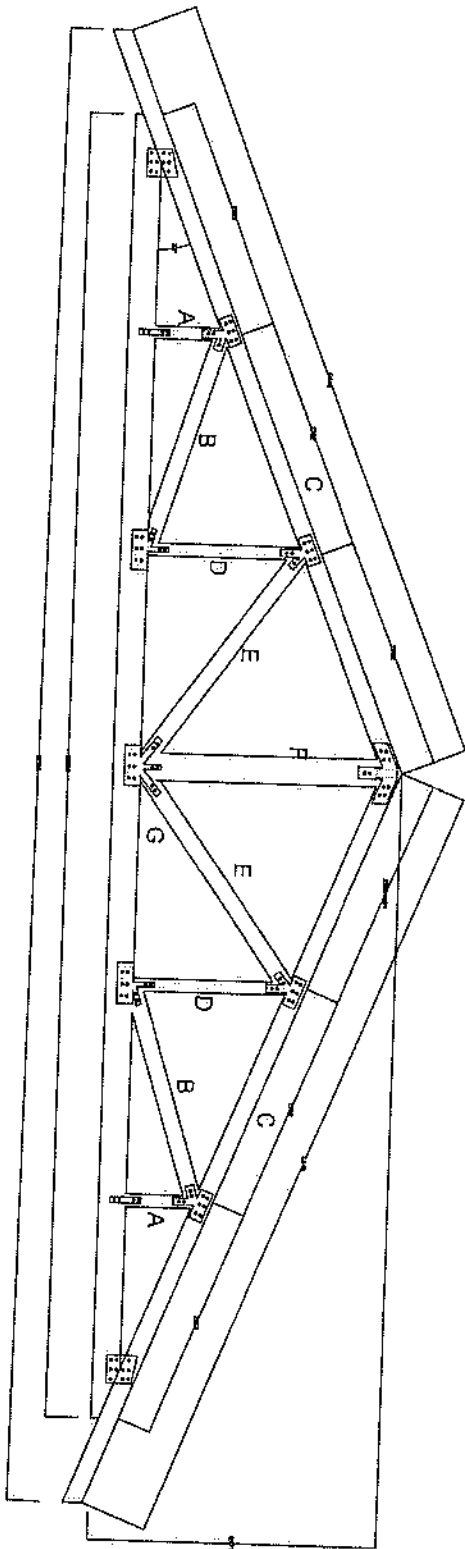

TRUSS DESCRIPTION				
ITEM	DESCRIPTION	DIMENSIONS(mm)	NUMBER PER TRUSS	LENGTH (mm)
A	STRUTWEB	50 X 100	2	991
B	STRUTWEB	50 X 100	2	2153
C	RAFTER	50 X 100	2	6640
D	STRUTWEB	50 X 100	2	1982
E	STRUTWEB	50 X 100	2	2622
F	KINGPOST	50 X 150	1	2873
G	BOTTOM CHORD	50 X 100	1	10300

NOTE

1. All work with tolerance = 25mm
2. All work with tolerance = 25mm
3. All work with tolerance = 25mm

DESIGN CONSULTANT

Ing. Saeed J. N. Hossain

Technical and Architectural Design
Represented by AED Engineering

Drawn by: Ing. Saeed J. N. Hossain
Checked by: Ing. Saeed J. N. Hossain

PROJECT

PROPOSED CONSTRUCTION
OF YOUTH CONNECT HUB

Location

MORISON BENDUSU
PALAIA DISTRICT

CLIENT

UNDP

DRAWING



DESCRIPTION

ROOF TRUSSES


Scale: 1:100

Date: JULY 2020

Drawing Number: P15
Revision:

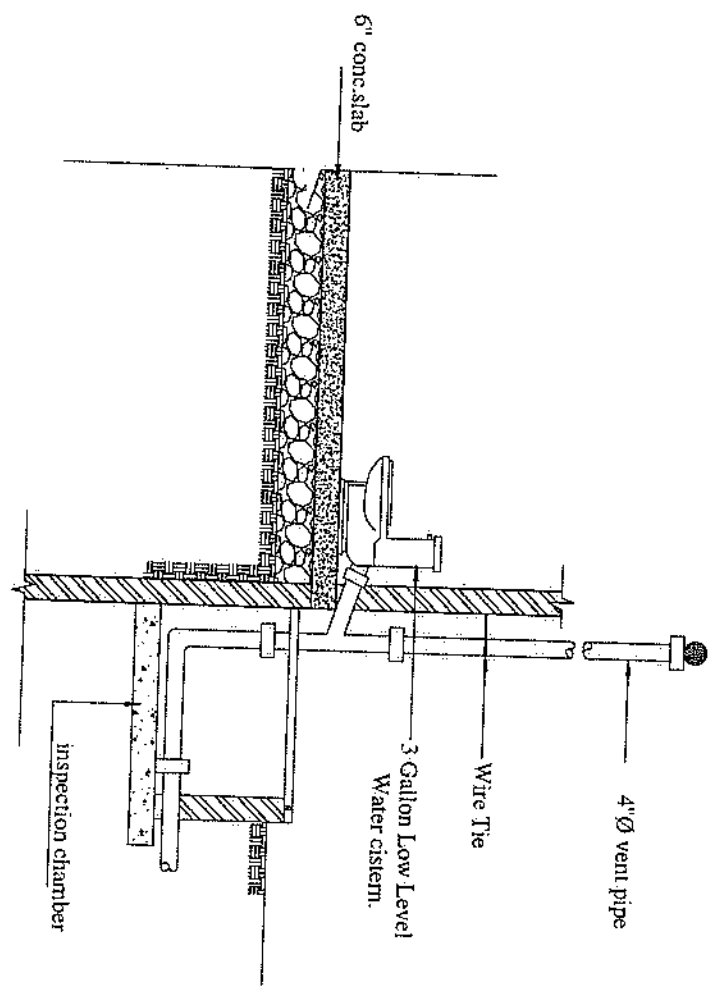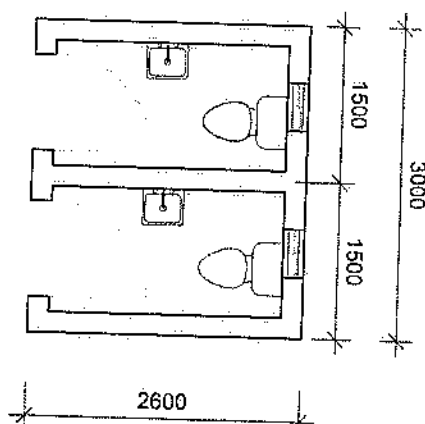

DETAILS OF W/C OUTLET

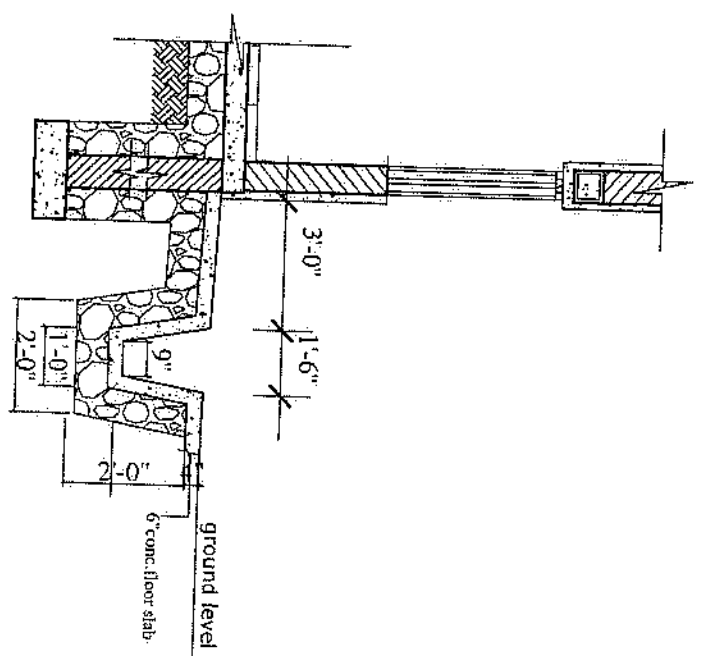

DRAINAGE DETAIL

NOTE

1. All work shall be in accordance with the latest edition of the relevant standards.
2. All work shall be in accordance with the latest edition of the relevant standards.
3. All work shall be in accordance with the latest edition of the relevant standards.

DESIGN CONSULTANT

by **Shirley L. M. Hoang**

Technical and Architectural Services

Engineering and Architecture

10/10/2020

10/10/2020

PROJECT

PROPOSED CONSTRUCTION OF YOUTH CONNECT HUB

Location

HONGKONG BENDJOU PALM DISTRICT

CLIENT

UNDP

DRAWING DESCRIPTION

EXTERNAL TOILET & PLUMBING DETAIL

Scale

1:100


Date:

JULY 2020


Drawing Number

P16

Revision

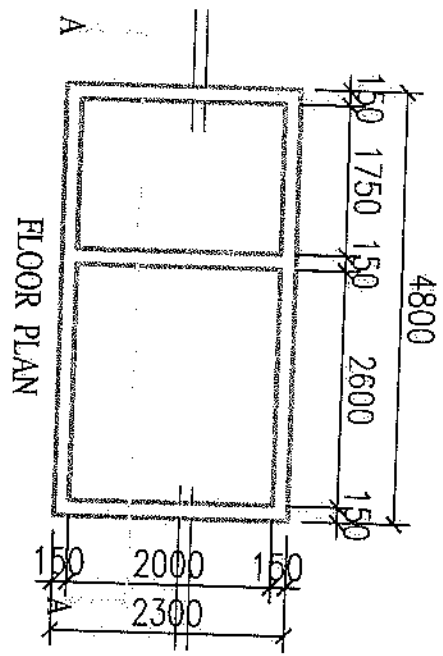

FLOOR PLAN

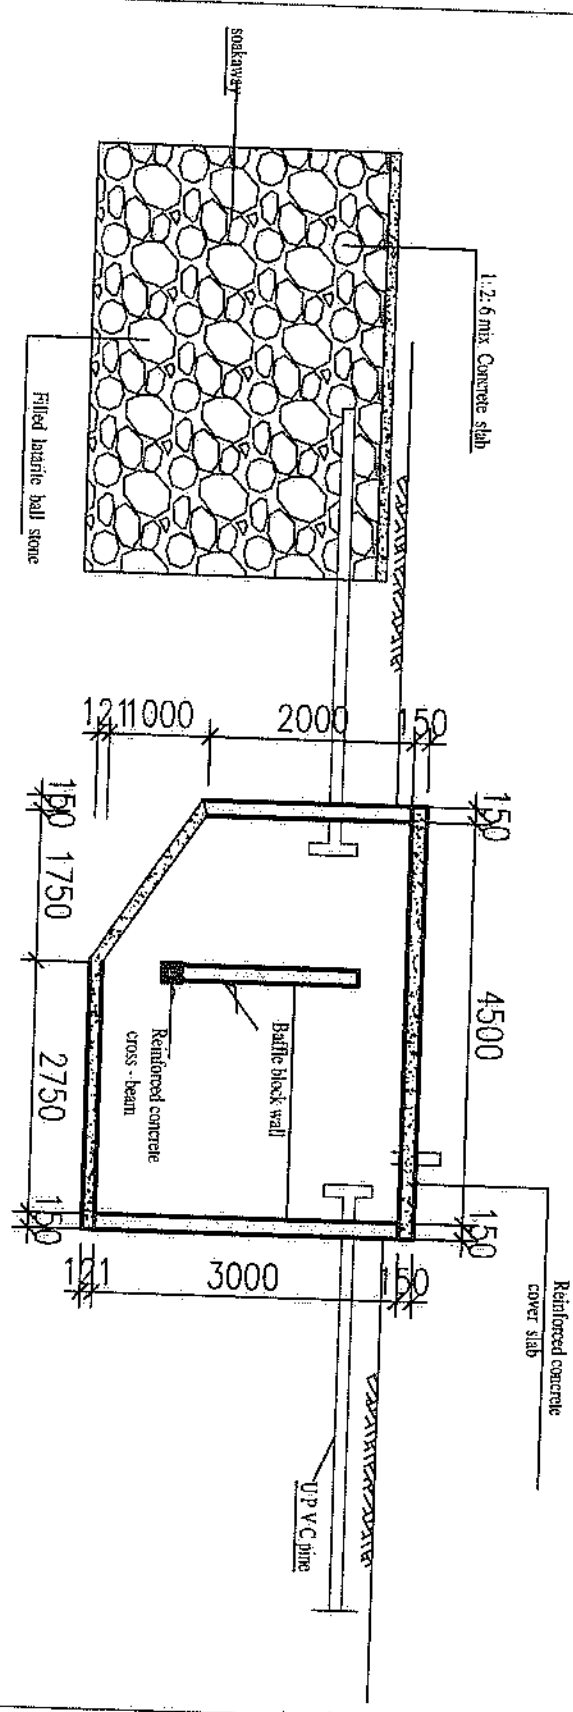

SECTION A-A

NOTE
 1. All work, new & existing, shall be in accordance with the latest specifications of the Government of India.
 2. Level to be maintained shall be as per the drawing.
 3. All work shall be done in accordance with the drawing.

DESIGN CONSULTANT	
Eng. S. K. S. S. S.	Technical and architectural design
Eng. S. K. S. S. S.	Engineering and architectural design
Eng. S. K. S. S. S.	Engineering and architectural design

PROJECT	
PROPOSED CONSTRUCTION OF YOUTH CONNECT HUB	

Location	
HOSUR ROAD, PALAKA DISTRICT	


CLIENT	
UNDP	

DRAWING DESCRIPTION	
SEPTIC AND SOAKWAY	

Scale: 1:100	
---------------------	--

Date: July 2020	
------------------------	--

Drawing Number: P17	
----------------------------	--

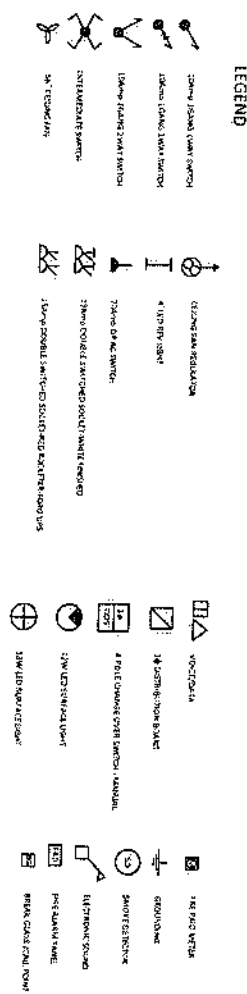

Revision	
Drawing Number	P18

TYPICAL WATER WELL

