



1 WAREHOUSE OVERALL GROUND FLOOR PLAN
SCALE 1:150

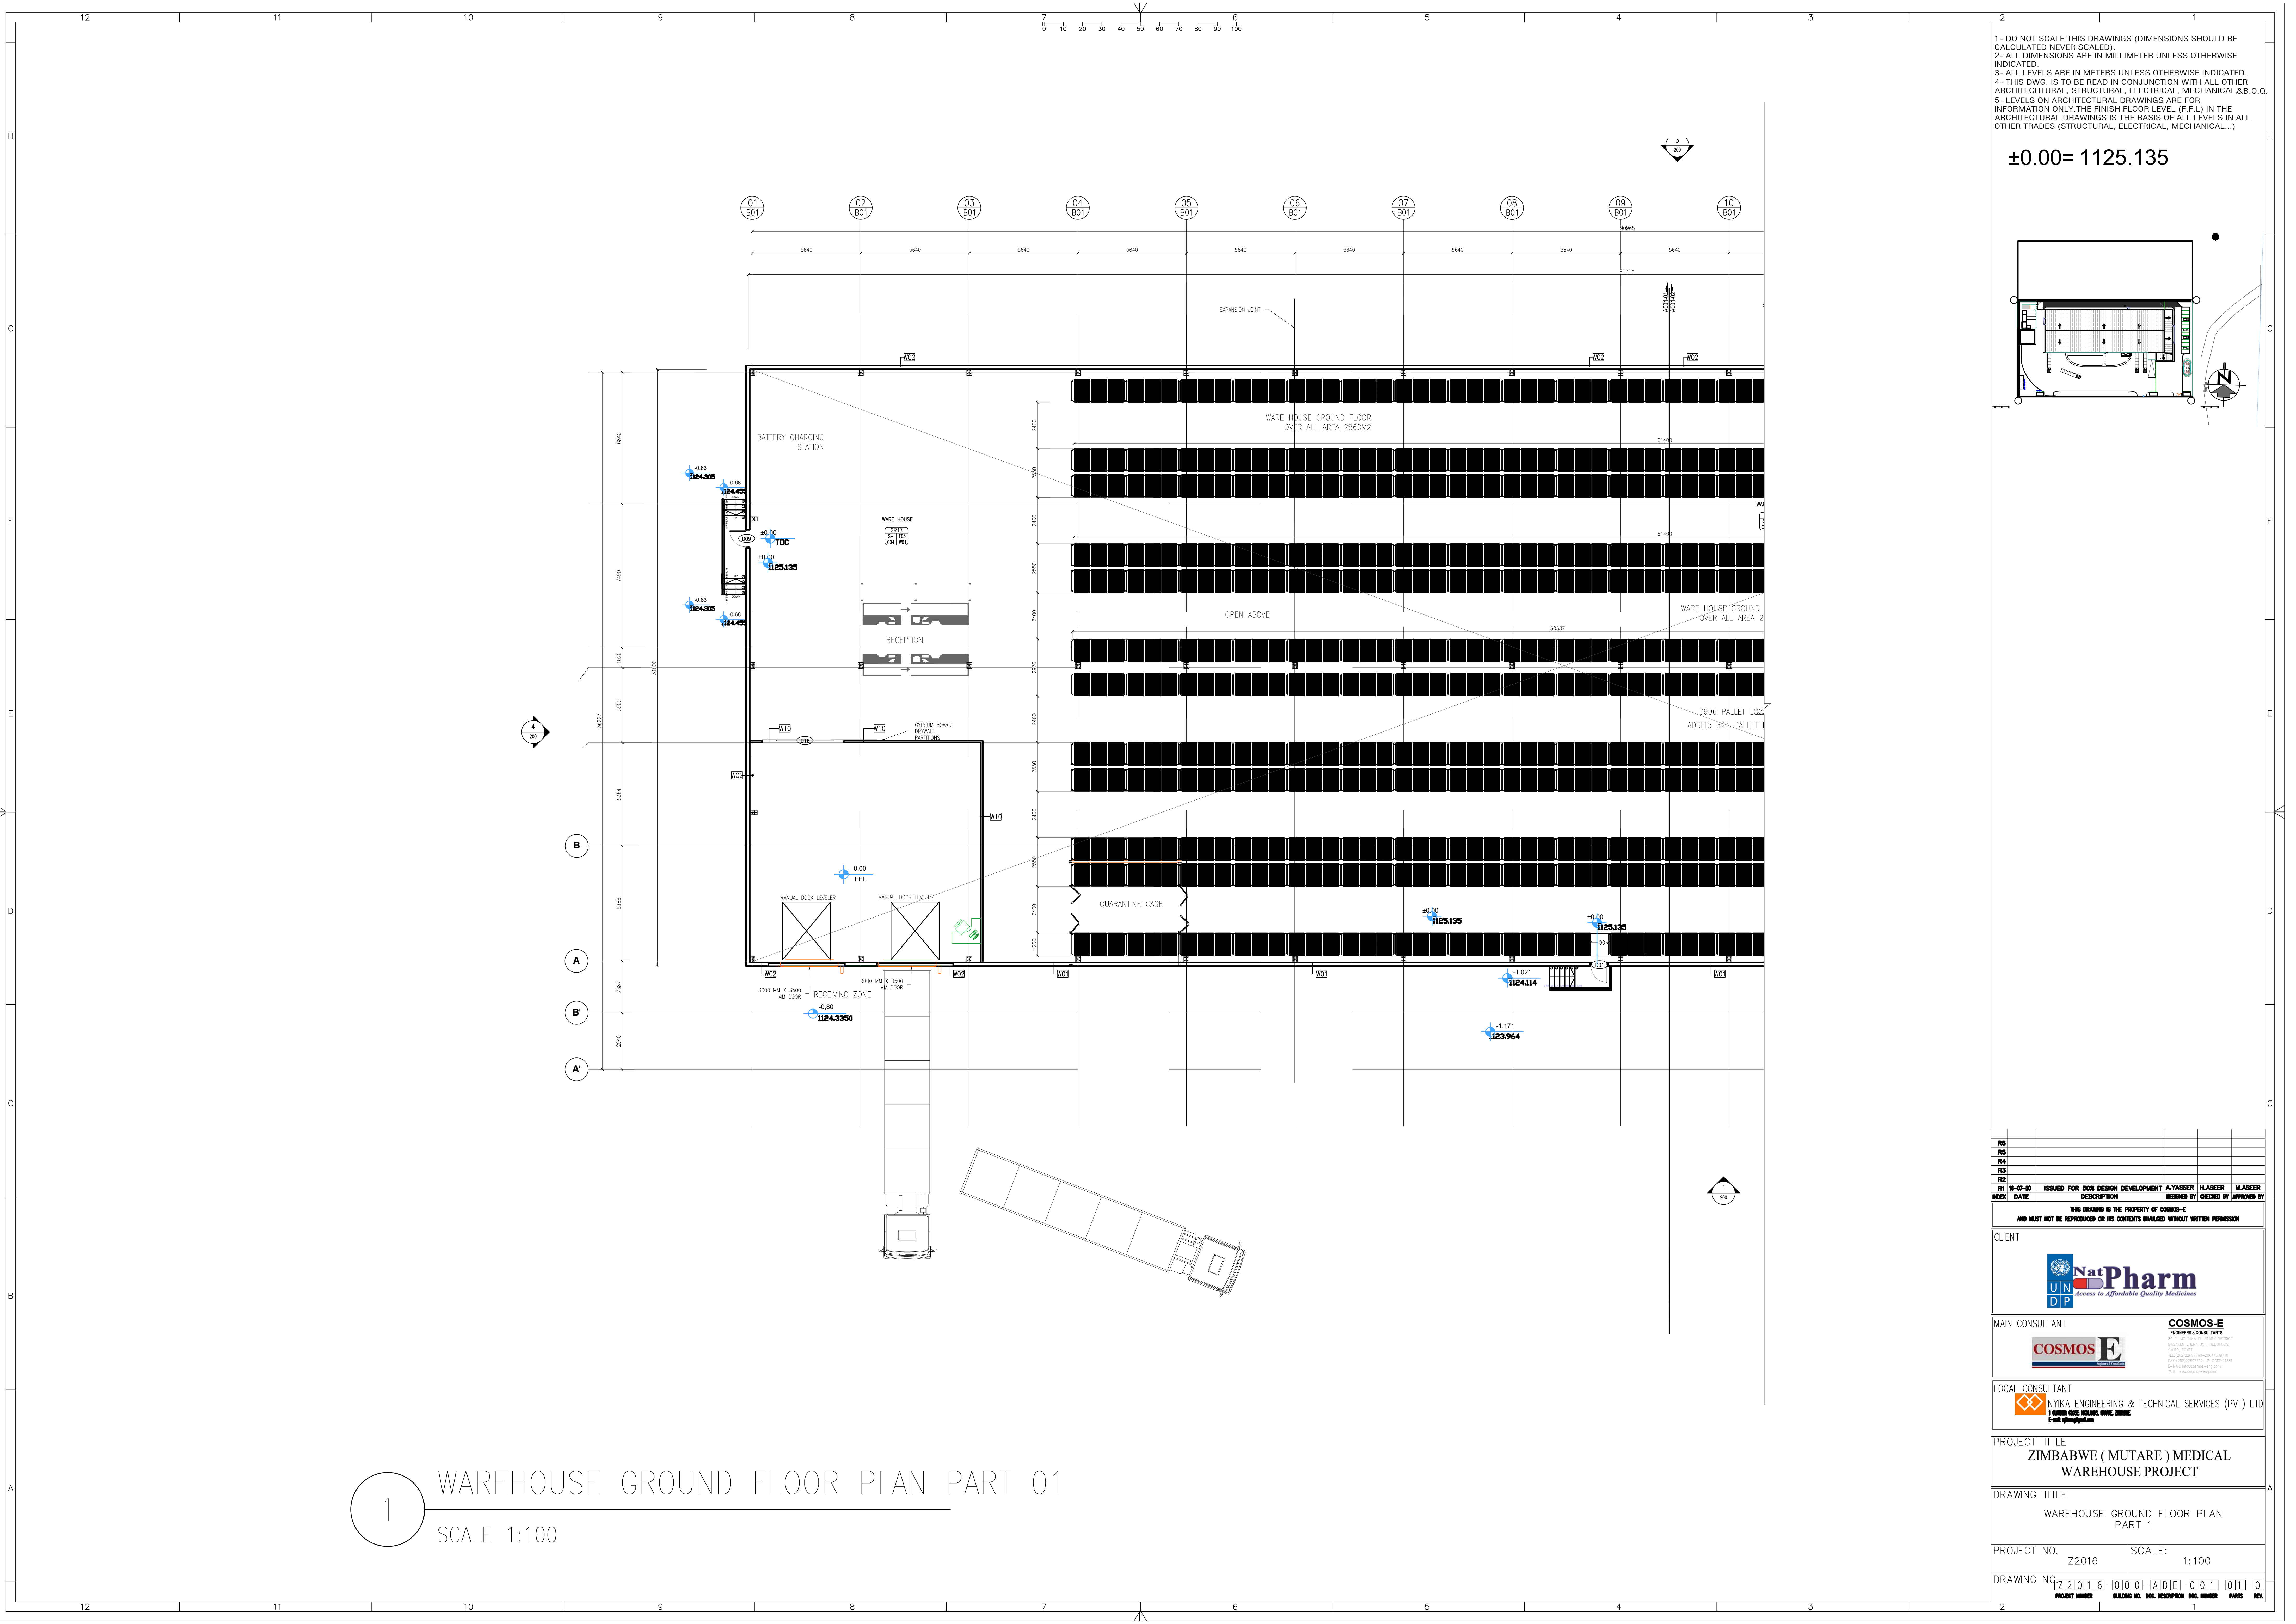



1 WAREHOUSE GROUND FLOOR PLAN PART 01
SCALE 1:100


- 1- DO NOT SCALE THIS DRAWINGS (DIMENSIONS SHOULD BE CALCULATED NEVER SCALED).
- 2- ALL DIMENSIONS ARE IN MILLIMETER UNLESS OTHERWISE INDICATED.
- 3- ALL LEVELS ARE IN METERS UNLESS OTHERWISE INDICATED.
- 4- THIS DWG. IS TO BE READ IN CONJUNCTION WITH ALL OTHER ARCHITECTURAL, STRUCTURAL, ELECTRICAL, MECHANICAL & B.O.Q.
- 5- LEVELS ON ARCHITECTURAL DRAWINGS ARE FOR INFORMATION ONLY. THE FINISH FLOOR LEVEL (F.F.L.) IN THE ARCHITECTURAL DRAWINGS IS THE BASIS OF ALL LEVELS IN ALL OTHER TRADES (STRUCTURAL, ELECTRICAL, MECHANICAL...)

±0.00= 1125.135

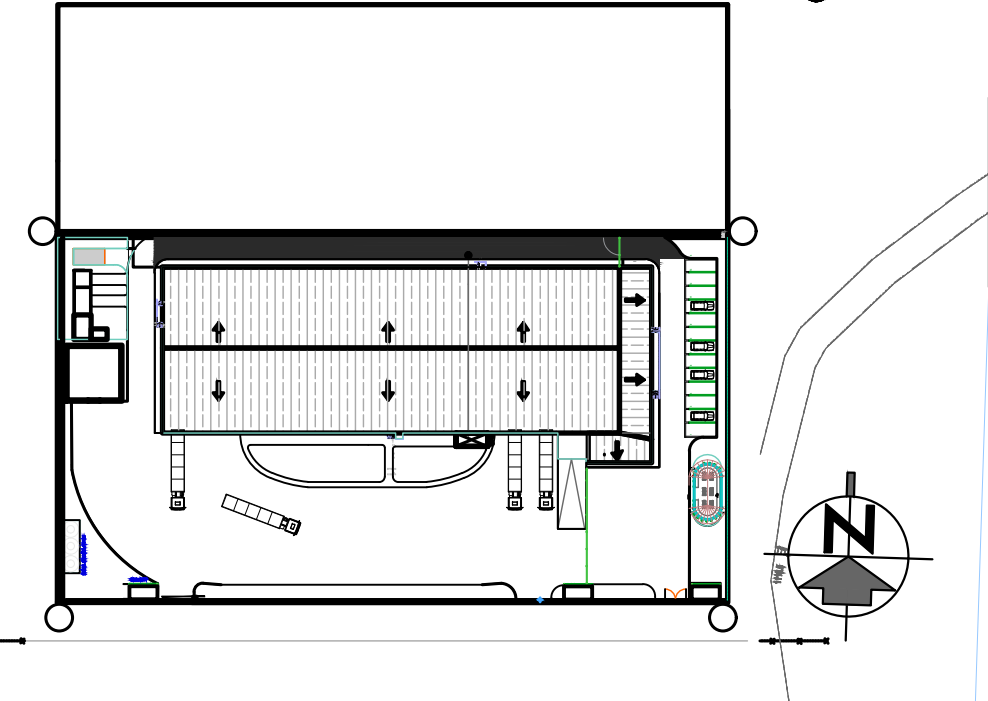

R6					
R5					
R4					
R3					
R2	18-01-20	ISSUED FOR 50% DESIGN DEVELOPMENT	A.YASSER	H.ASHER	M.ASHER
R1	INDEX	DATE	DESCRIPTION	DESIGNED BY	CHECKED BY
THIS DRAWING IS THE PROPERTY OF COSMOS-E AND MUST NOT BE REPRODUCED OR ITS CONTENTS DISCLOSED WITHOUT WRITTEN PERMISSION					
CLIENT					
 NatPharm <i>Access to Affordable Quality Medicines</i>					
MAIN CONSULTANT			COSMOS-E ENGINEERS & CONSULTANTS 100, ELIZABETH WALKER DRIVE, SUITE 100, WILLOW PARK, NORTHERN VIRGINIA, VA 22192, USA TEL: (703) 441-1100 FAX: (703) 441-1101 WWW.COSMOS-ENGINEERS.COM		
					
LOCAL CONSULTANT					
 NYKA ENGINEERING & TECHNICAL SERVICES (PVT) LTD 1 GARDEN GATE, HARARE, ZIMBABWE E-mail: nyka@nyka.com					
PROJECT TITLE					
ZIMBABWE (MUTARE) MEDICAL WAREHOUSE PROJECT					
DRAWING TITLE					
WAREHOUSE GROUND FLOOR PLAN PART 1					
PROJECT NO.			SCALE:		
Z2016			1:100		
DRAWING NO.					
Z2016-000-AD-E-001-01-01					
PROJECT NUMBER		BUILDING NO.		DOC. DESCRIPTION	DOC. NUMBER

 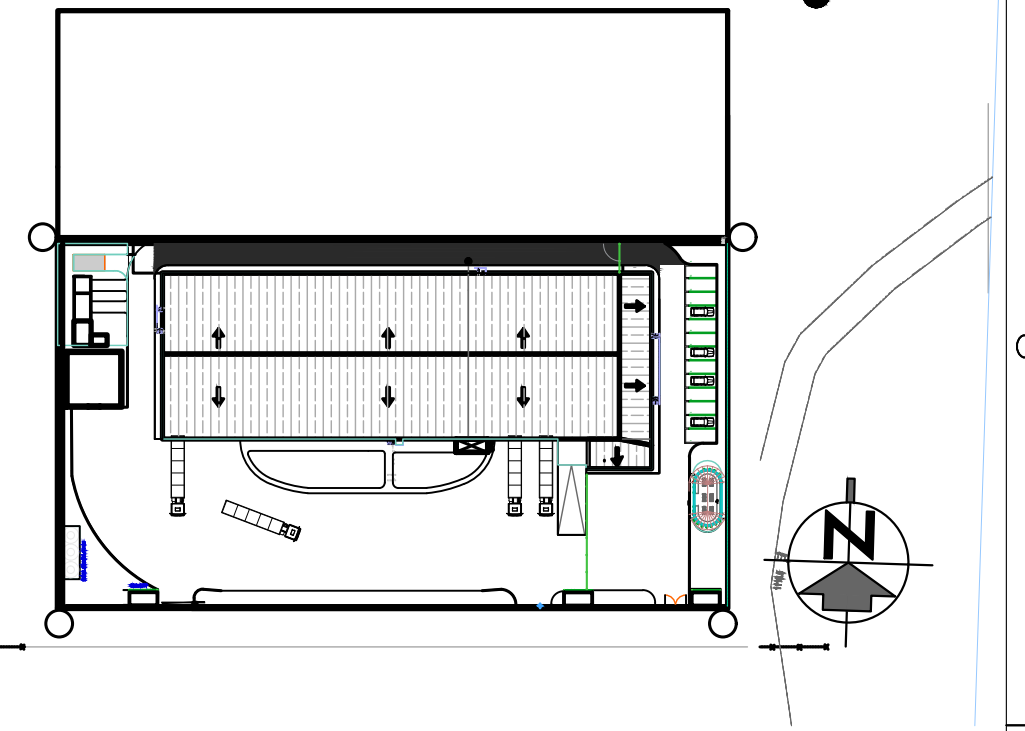

$$\pm 0.00 = 1125.135$$
[illegible]

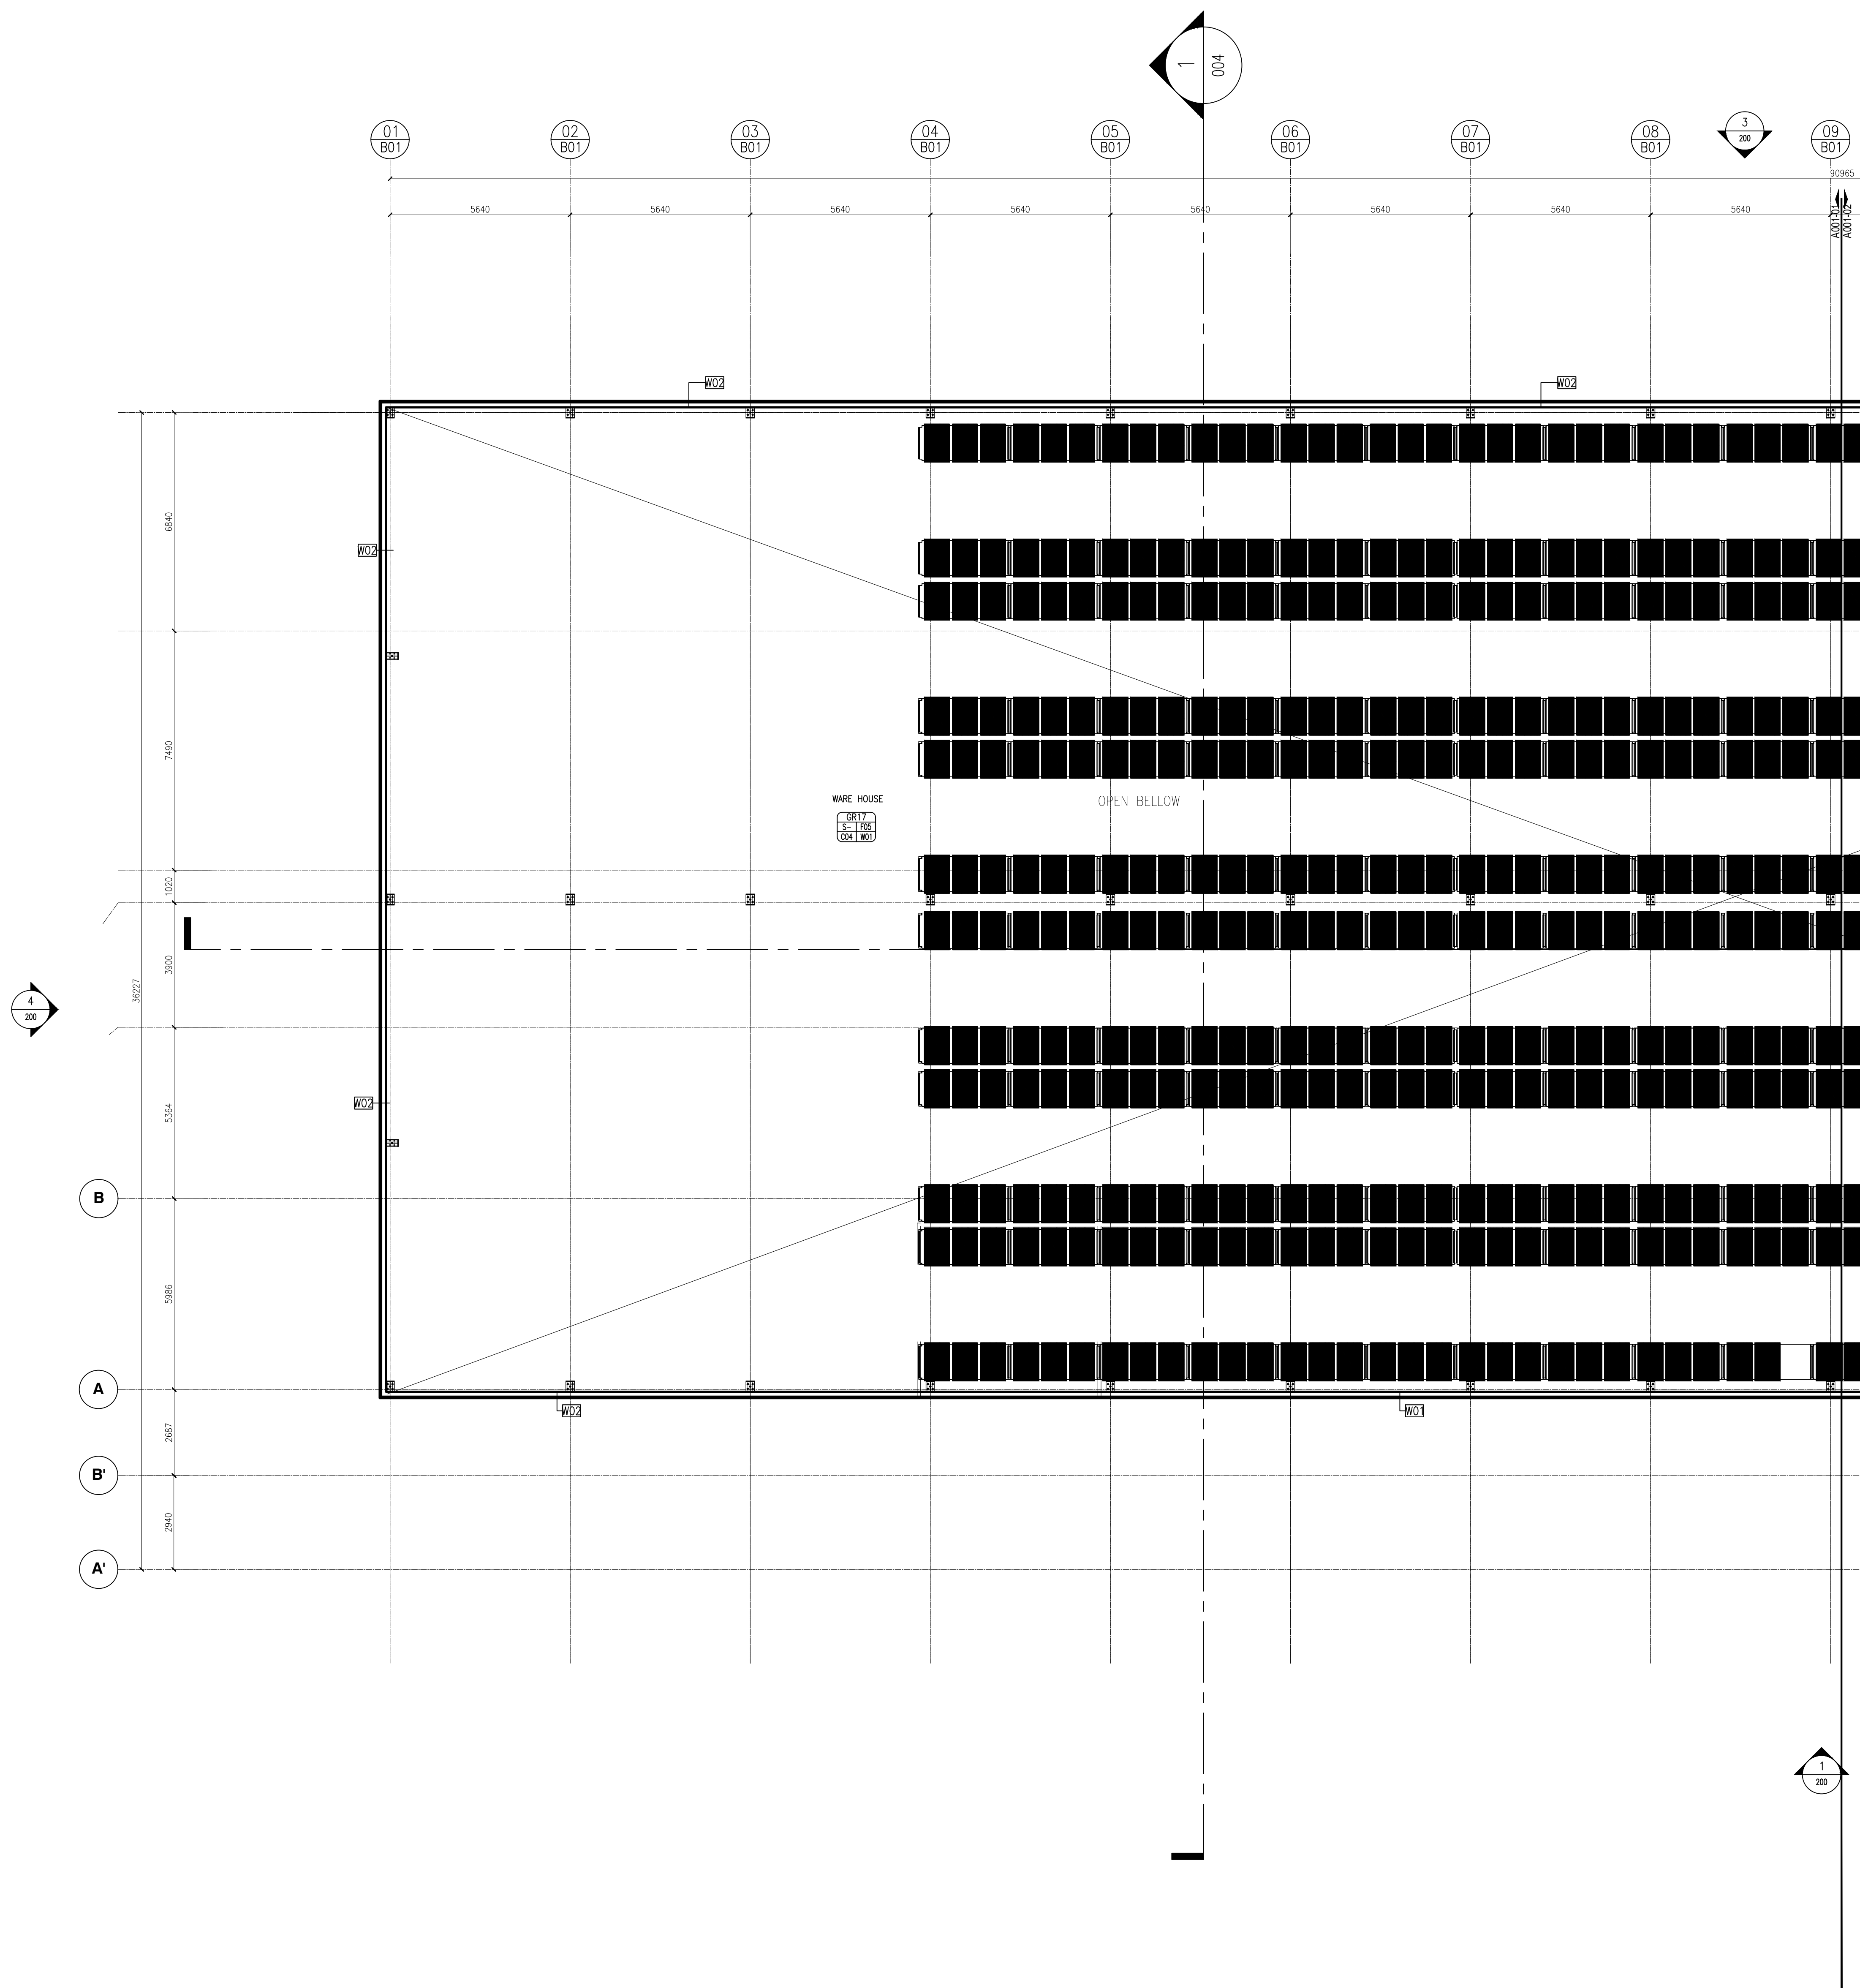


1 WAREHOUSE FIRST FLOOR PLAN PART 01
SCALE 1:100

1- DO NOT SCALE THIS DRAWINGS (DIMENSIONS SHOULD BE CALCULATED NEVER SCALED).
2- ALL DIMENSIONS ARE IN MILLIMETER UNLESS OTHERWISE INDICATED.
3- ALL LEVELS ARE IN METERS UNLESS OTHERWISE INDICATED.
4- THIS DWG. IS TO BE READ IN CONJUNCTION WITH ALL OTHER ARCHITECTURAL, STRUCTURAL, ELECTRICAL, MECHANICAL.&B.O.O.
5- LEVELS ON ARCHITECTURAL DRAWINGS ARE FOR INFORMATION ONLY.THE FINISH FLOOR LEVEL (F.F.L) IN THE ARCHITECTURAL DRAWINGS IS THE BASIS OF ALL LEVELS IN ALL OTHER TRADES (STRUCTURAL, ELECTRICAL, MECHANICAL...)

±0.00= 1125.135

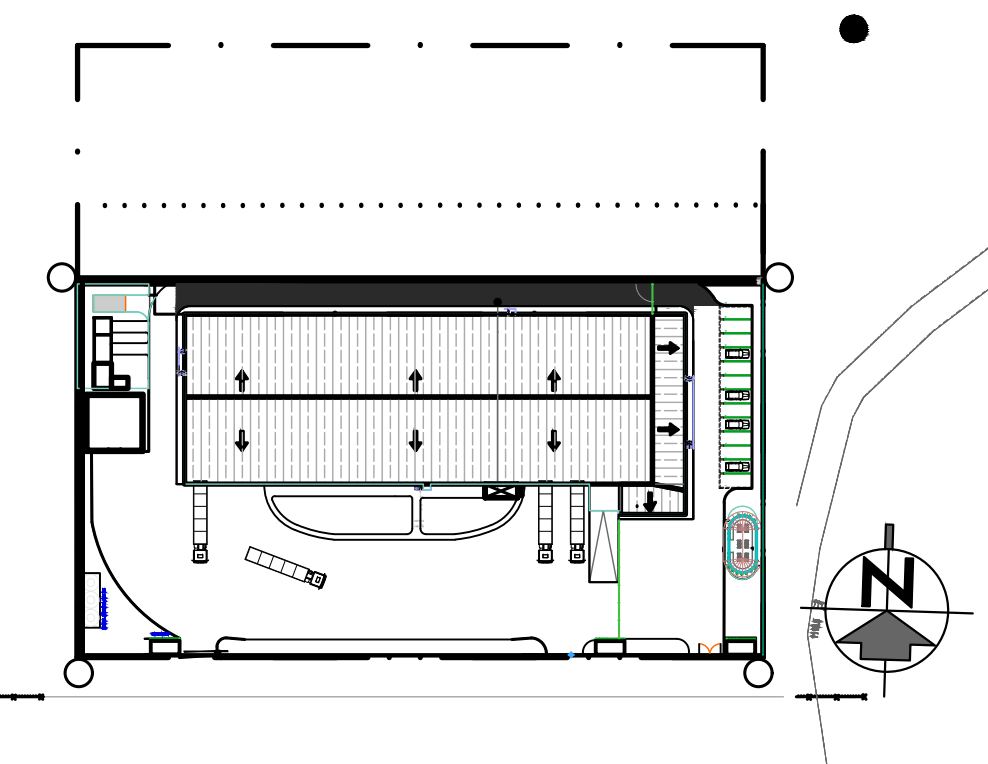


R6					
R5					
R4					
R3					
R2					
R1	18-07-20	ISSUED FOR 50% DESIGN DEVELOPMENT	A.YASSER	M.ASEER	M.ASEER
INDEX	DATE	DESCRIPTION	DESIGNED BY	CHECKED BY	APPROVED BY
THIS DRAWING IS THE PROPERTY OF COSMOS-E AND MUST NOT BE REPRODUCED OR ITS CONTENTS DIVULGED WITHOUT WRITTEN PERMISSION					
CLIENT					
 NatPharm <i>Access to Affordable Quality Medicines</i>					
MAIN CONSULTANT			COSMOS-E ENGINEERS & CONSULTANTS 100, EL-DOKKI, EL-DOKKI, CAIRO, EGYPT TEL: 0020 2374 1111 FAX: 0020 2374 1111 E-MAIL: info@cosmos-e.com WWW: www.cosmos-e.com		
LOCAL CONSULTANT			 NYIKA ENGINEERING & TECHNICAL SERVICES (PVT) LTD 1 GARDEN GATE, HARARE, HARARE, ZIMBABWE E-mail: nyika@nyika.co.zw		
PROJECT TITLE					
ZIMBABWE (MUTARE) MEDICAL WAREHOUSE PROJECT					
DRAWING TITLE					
WAREHOUSE FIRST FLOOR PLAN PART 1					
PROJECT NO.			SCALE:		
Z2016			1:100		
DRAWING NO					
Z210116-01010-0101E-01012-011-01					
PROJECT NUMBER		BUILDING NO.		DOC. DESCRIPTION	DOC. NUMBER

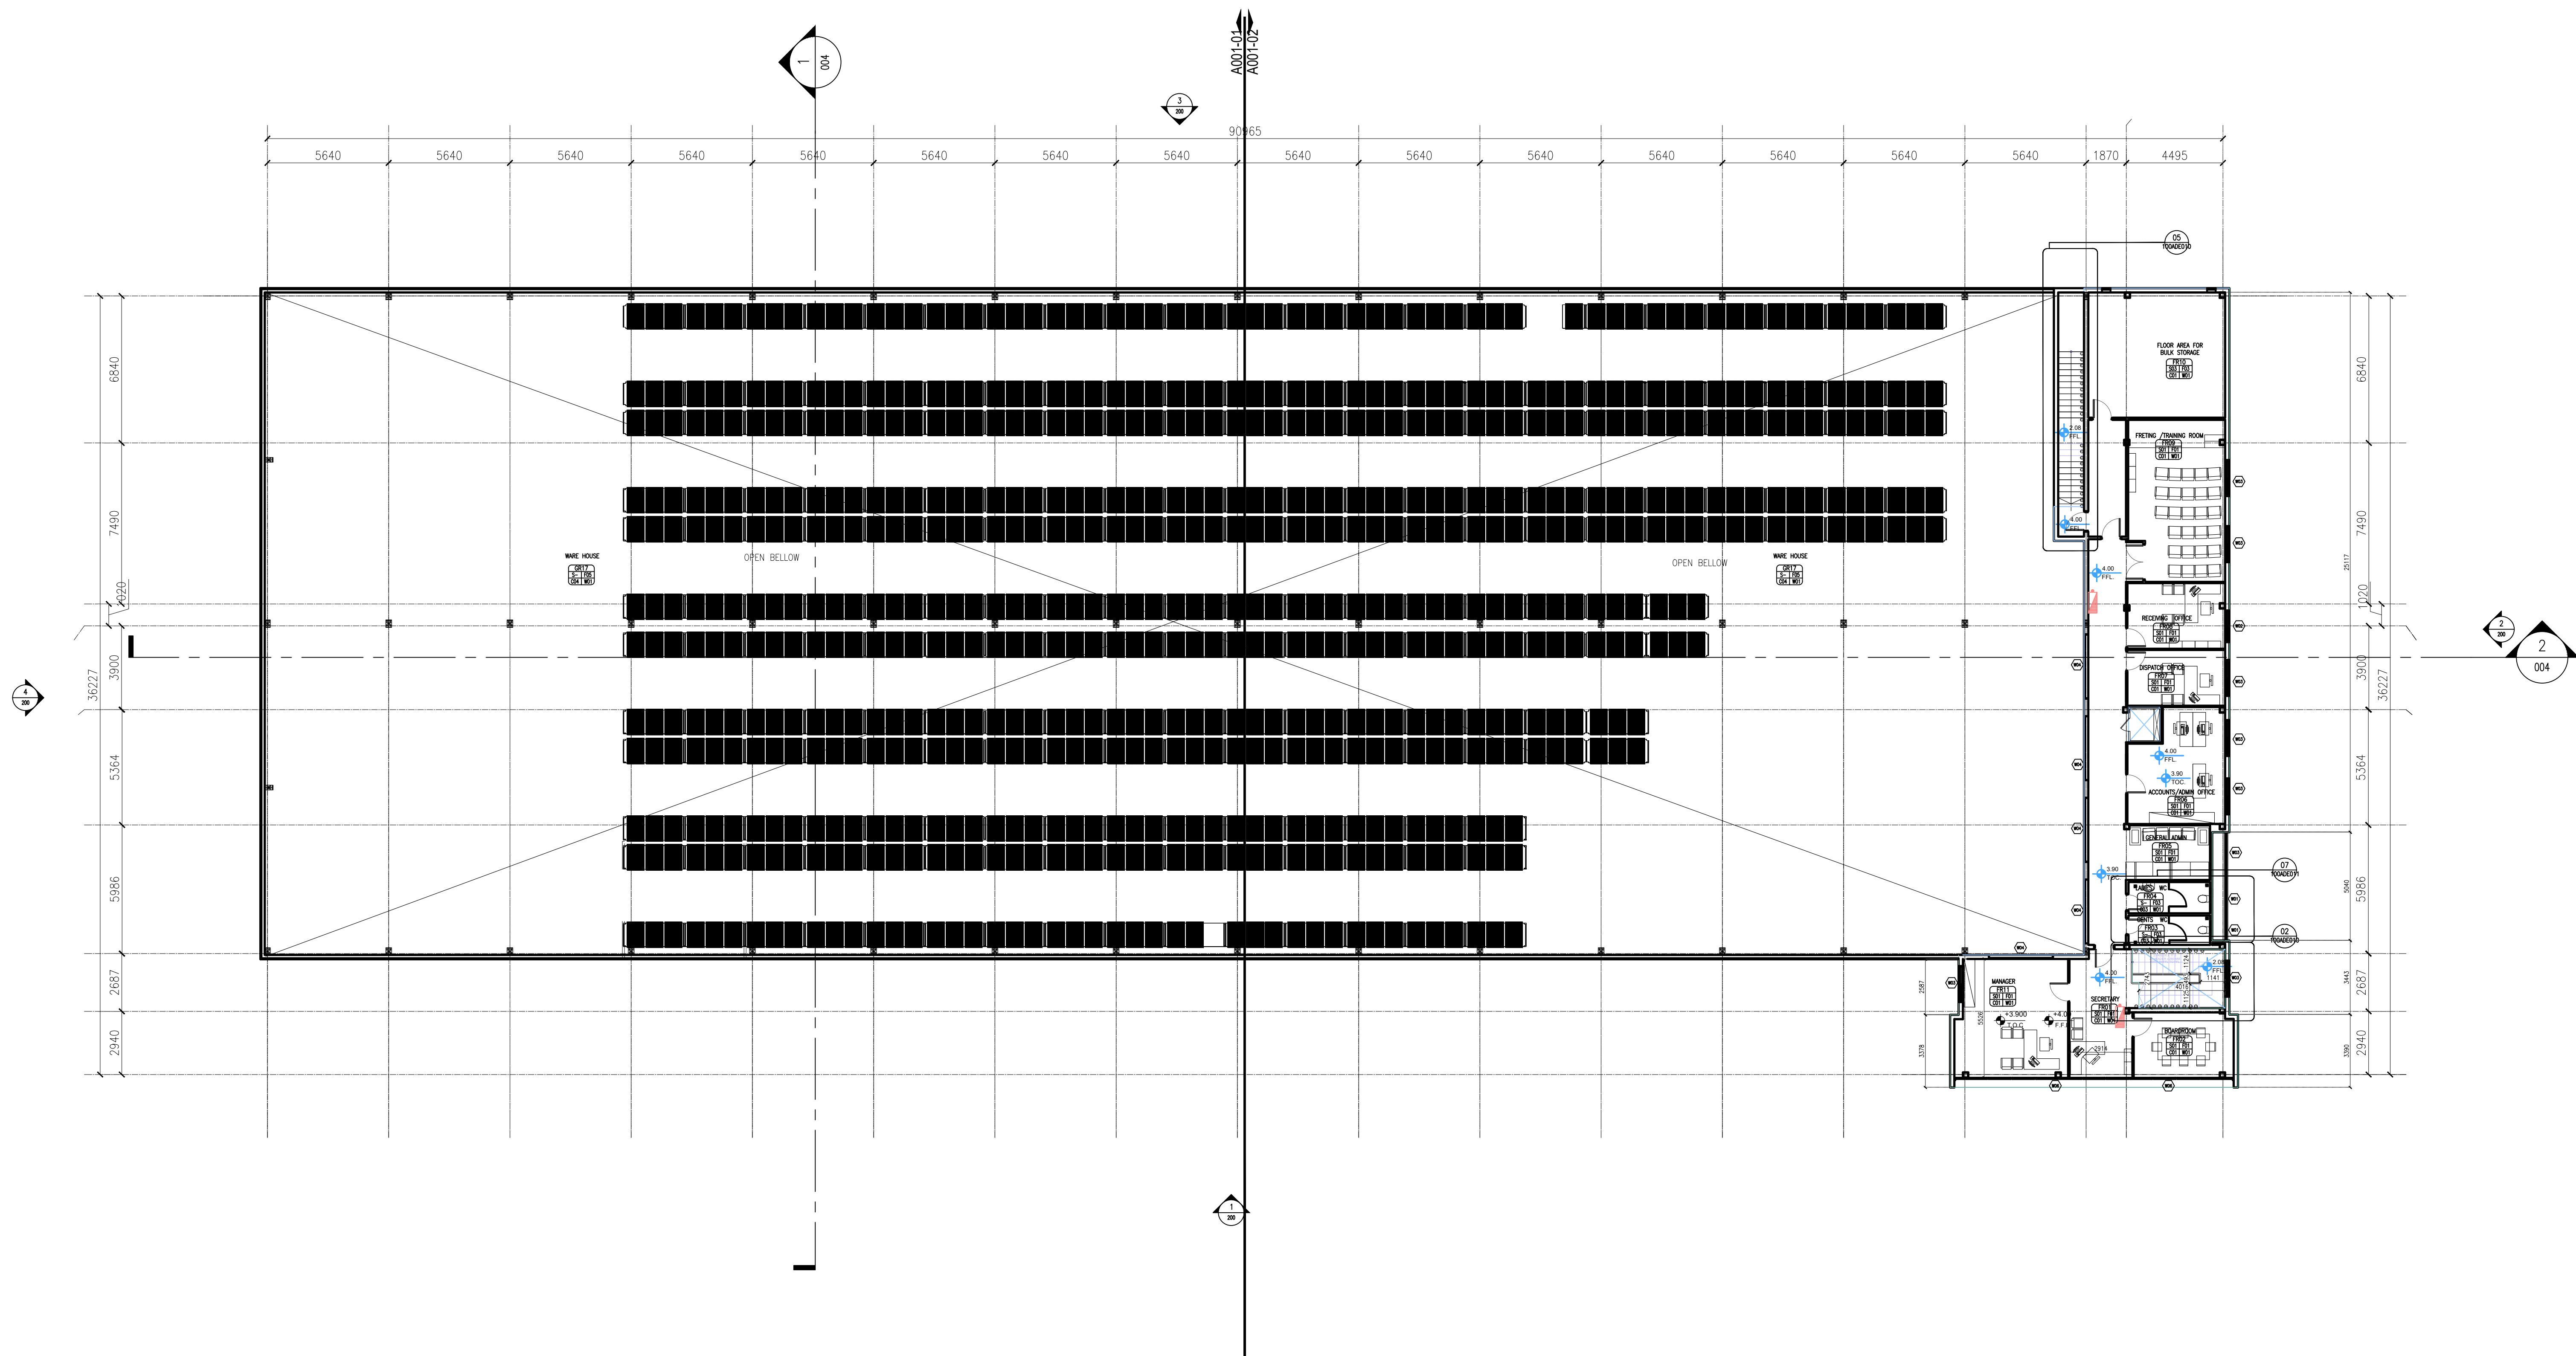

1 WAREHOUSE OVERALL FIRST FLOOR PLAN
SCALE 1:150

1- DO NOT SCALE THIS DRAWINGS (DIMENSIONS SHOULD BE CALCULATED NEVER SCALED).
2- ALL DIMENSIONS ARE IN MILLIMETER UNLESS OTHERWISE INDICATED.
3- ALL LEVELS ARE IN METERS UNLESS OTHERWISE INDICATED.
4- THIS DWG. IS TO BE READ IN CONJUNCTION WITH ALL OTHER ARCHITECTURAL, STRUCTURAL, ELECTRICAL, MECHANICAL.&B.O.O.
5- LEVELS ON ARCHITECTURAL DRAWINGS ARE FOR INFORMATION ONLY.THE FINISH FLOOR LEVEL (F.F.L) IN THE ARCHITECTURAL DRAWINGS IS THE BASIS OF ALL LEVELS IN ALL OTHER TRADES (STRUCTURAL, ELECTRICAL, MECHANICAL...)

±0.00= 1125.135

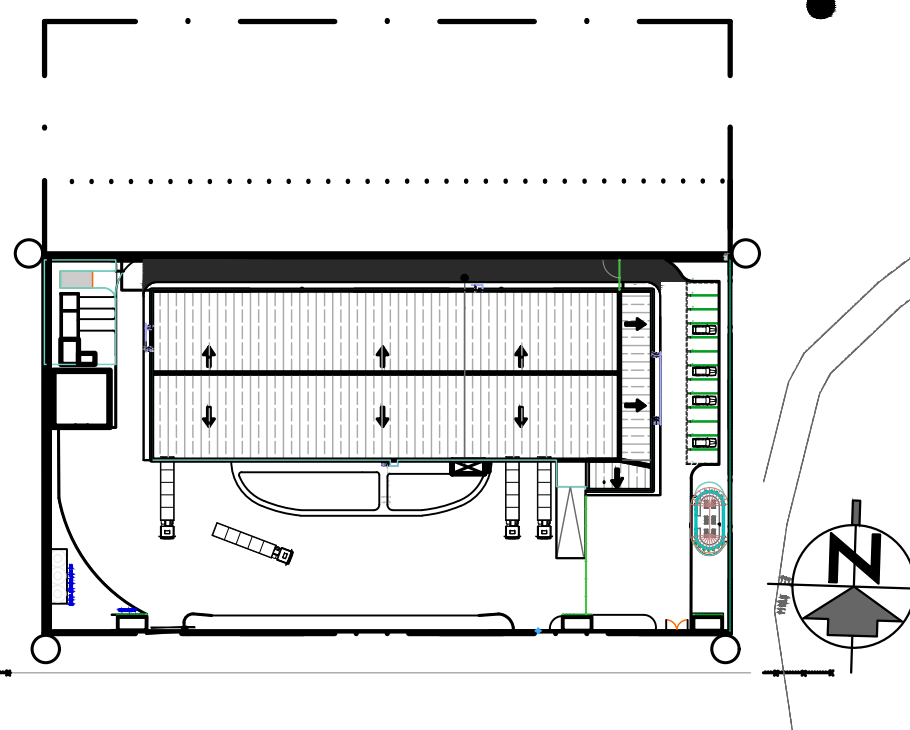


R6					
R5					
R4					
R3					
R2					
R1	18-07-20	ISSUED FOR 50% DESIGN DEVELOPMENT	A.YASSER	M.ASEER	M.ASEER
NO	DATE	DESCRIPTION	DESIGNED BY	CHECKED BY	APPROVED BY
THIS DRAWING IS THE PROPERTY OF COSMOS-E AND MUST NOT BE REPRODUCED OR ITS CONTENTS DIVULGED WITHOUT WRITTEN PERMISSION					
CLIENT					
					
MAIN CONSULTANT			COSMOS-E ENGINEERS & CONSULTANTS 10, EL-DOKKI STREET, EL-DOKKI, CAIRO, EGYPT TEL: (0020) 2030 1000 FAX: (0020) 2030 1001 EMAIL: info@cosmos-e.com EGYPT WWW.COSMOS-E.COM		
LOCAL CONSULTANT					
 NYKA ENGINEERING & TECHNICAL SERVICES (PVT) LTD 1 GURGAO CITY, GURGAO, HARYANA, INDIA TEL: 0124 6600000					
PROJECT TITLE					
ZIMBABWE (MUTARE) MEDICAL WAREHOUSE PROJECT					
DRAWING TITLE					
WAREHOUSE OVERALL FIRST FLOOR PLAN					
PROJECT NO.		SCALE:			
Z2016		1:150			
DRAWING NO.		Z[2]01[6]-[0]0[0]-[A]0[E]-[0]0[2]-[0]0[0]			
PROJECT NUMBER		BUILDING NO.		DOC. DESCRIPTION	DOC. NUMBER
PARTS		NO.			




1 WAREHOUSE FIRST FLOOR PLAN PART 02
SCALE 1:100

- 1- DO NOT SCALE THIS DRAWINGS (DIMENSIONS SHOULD BE CALCULATED NEVER SCALED).
- 2- ALL DIMENSIONS ARE IN MILLIMETER UNLESS OTHERWISE INDICATED.
- 3- ALL LEVELS ARE IN METERS UNLESS OTHERWISE INDICATED.
- 4- THIS DWG. IS TO BE READ IN CONJUNCTION WITH ALL OTHER ARCHITECTURAL, STRUCTURAL, ELECTRICAL, MECHANICAL & B.O.C.
- 5- LEVELS ON ARCHITECTURAL DRAWINGS ARE FOR INFORMATION ONLY. THE FINISH FLOOR LEVEL (F.F.L) IN THE ARCHITECTURAL DRAWINGS IS THE BASIS OF ALL LEVELS IN ALL OTHER TRADES (STRUCTURAL, ELECTRICAL, MECHANICAL...)



±0.00= 1125.135

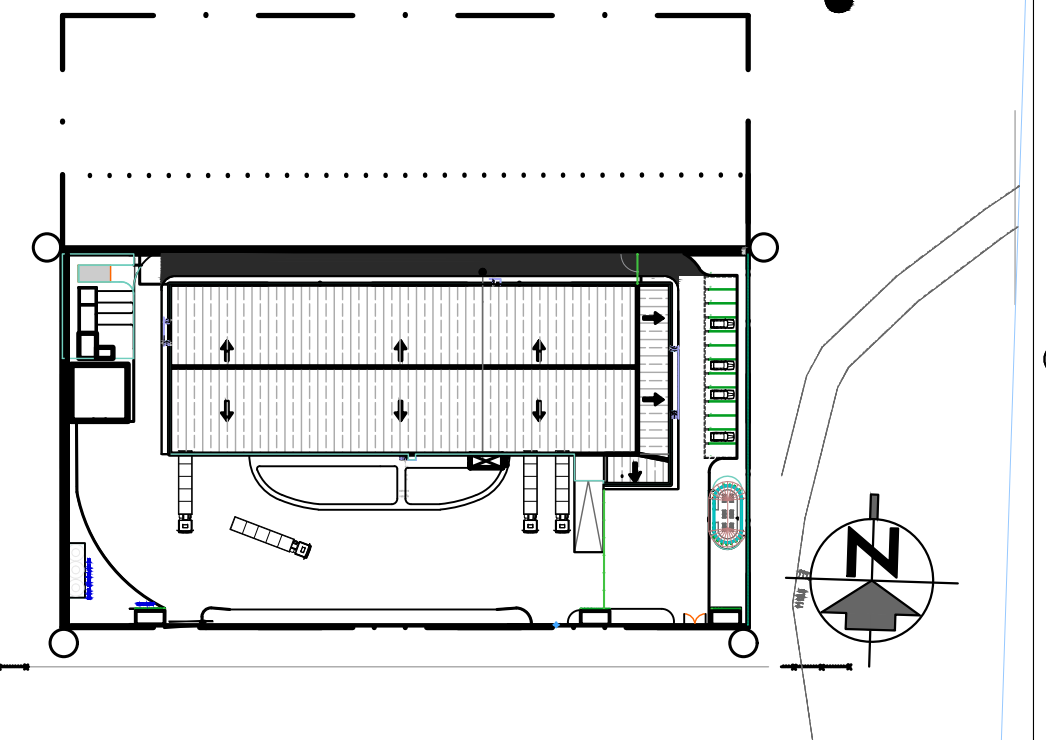

5					
4					
3					
2					
1	18-07-20	ISSUED FOR 50% DESIGN DEVELOPMENT	A.YASSER	M.ASEER	M.ASEER
0	DATE	DESCRIPTION	DESIGNED BY	CHECKED BY	APPROVED BY
THIS DRAWING IS THE PROPERTY OF COSMOS-E AND MUST NOT BE REPRODUCED OR ITS CONTENTS DISCLOSED WITHOUT WRITTEN PERMISSION					
CLIENT					
 NatPharm <i>Access to Affordable Quality Medicines</i>					
MAIN CONSULTANT					
 COSMOS-E ENGINEERS & CONSULTANTS 100, EL DOKKI STREET, EL DOKKI, CAIRO, EGYPT TEL: +202 27357000 - 27357001 FAX: +202 27357002 - 27357003 E-MAIL: info@cosmos-e.com WWW: www.cosmos-e.com					
LOCAL CONSULTANT					
 NYIKA ENGINEERING & TECHNICAL SERVICES (PVT) LTD 1 GARDEN COURT, HARARE, ZIMBABWE E-mail: nyika@nyika.co.zw					
PROJECT TITLE					
ZIMBABWE (MUTARE) MEDICAL WAREHOUSE PROJECT					
DRAWING TITLE					
WAREHOUSE FIRST FLOOR PLAN PART 2					
PROJECT NO.			SCALE:		
Z2016			1:100		
DRAWING NO. Z[2016]-[010]-[A01E]-[012]-[012]-[012]					
PROJECT NUMBER	BUILDING NO.	DOC. DESCRIPTION	DOC. NUMBER	PARTS	NOX

 

- 1- DO NOT SCALE THIS DRAWINGS (DIMENSIONS SHOULD BE CALCULATED NEVER SCALED).
- 2- ALL DIMENSIONS ARE IN MILLIMETER UNLESS OTHERWISE INDICATED.
- 3- ALL LEVELS ARE IN METERS UNLESS OTHERWISE INDICATED.
- 4- ALL DRAWING IS TO BE READ IN CONJUNCTION WITH ALL OTHER ARCHITECTURAL, STRUCTURAL, ELECTRICAL, MECHANICAL & O.D.
- 5- LEVELS ON ARCHITECTURAL DRAWINGS ARE FOR INFORMATION ONLY. THE FINISH FLOOR LEVEL (F.F.L) IN THE ARCHITECTURAL DRAWINGS IS THE BASIS OF ALL LEVELS IN ALL OTHER TRADES (STRUCTURAL, ELECTRICAL, MECHANICAL...)
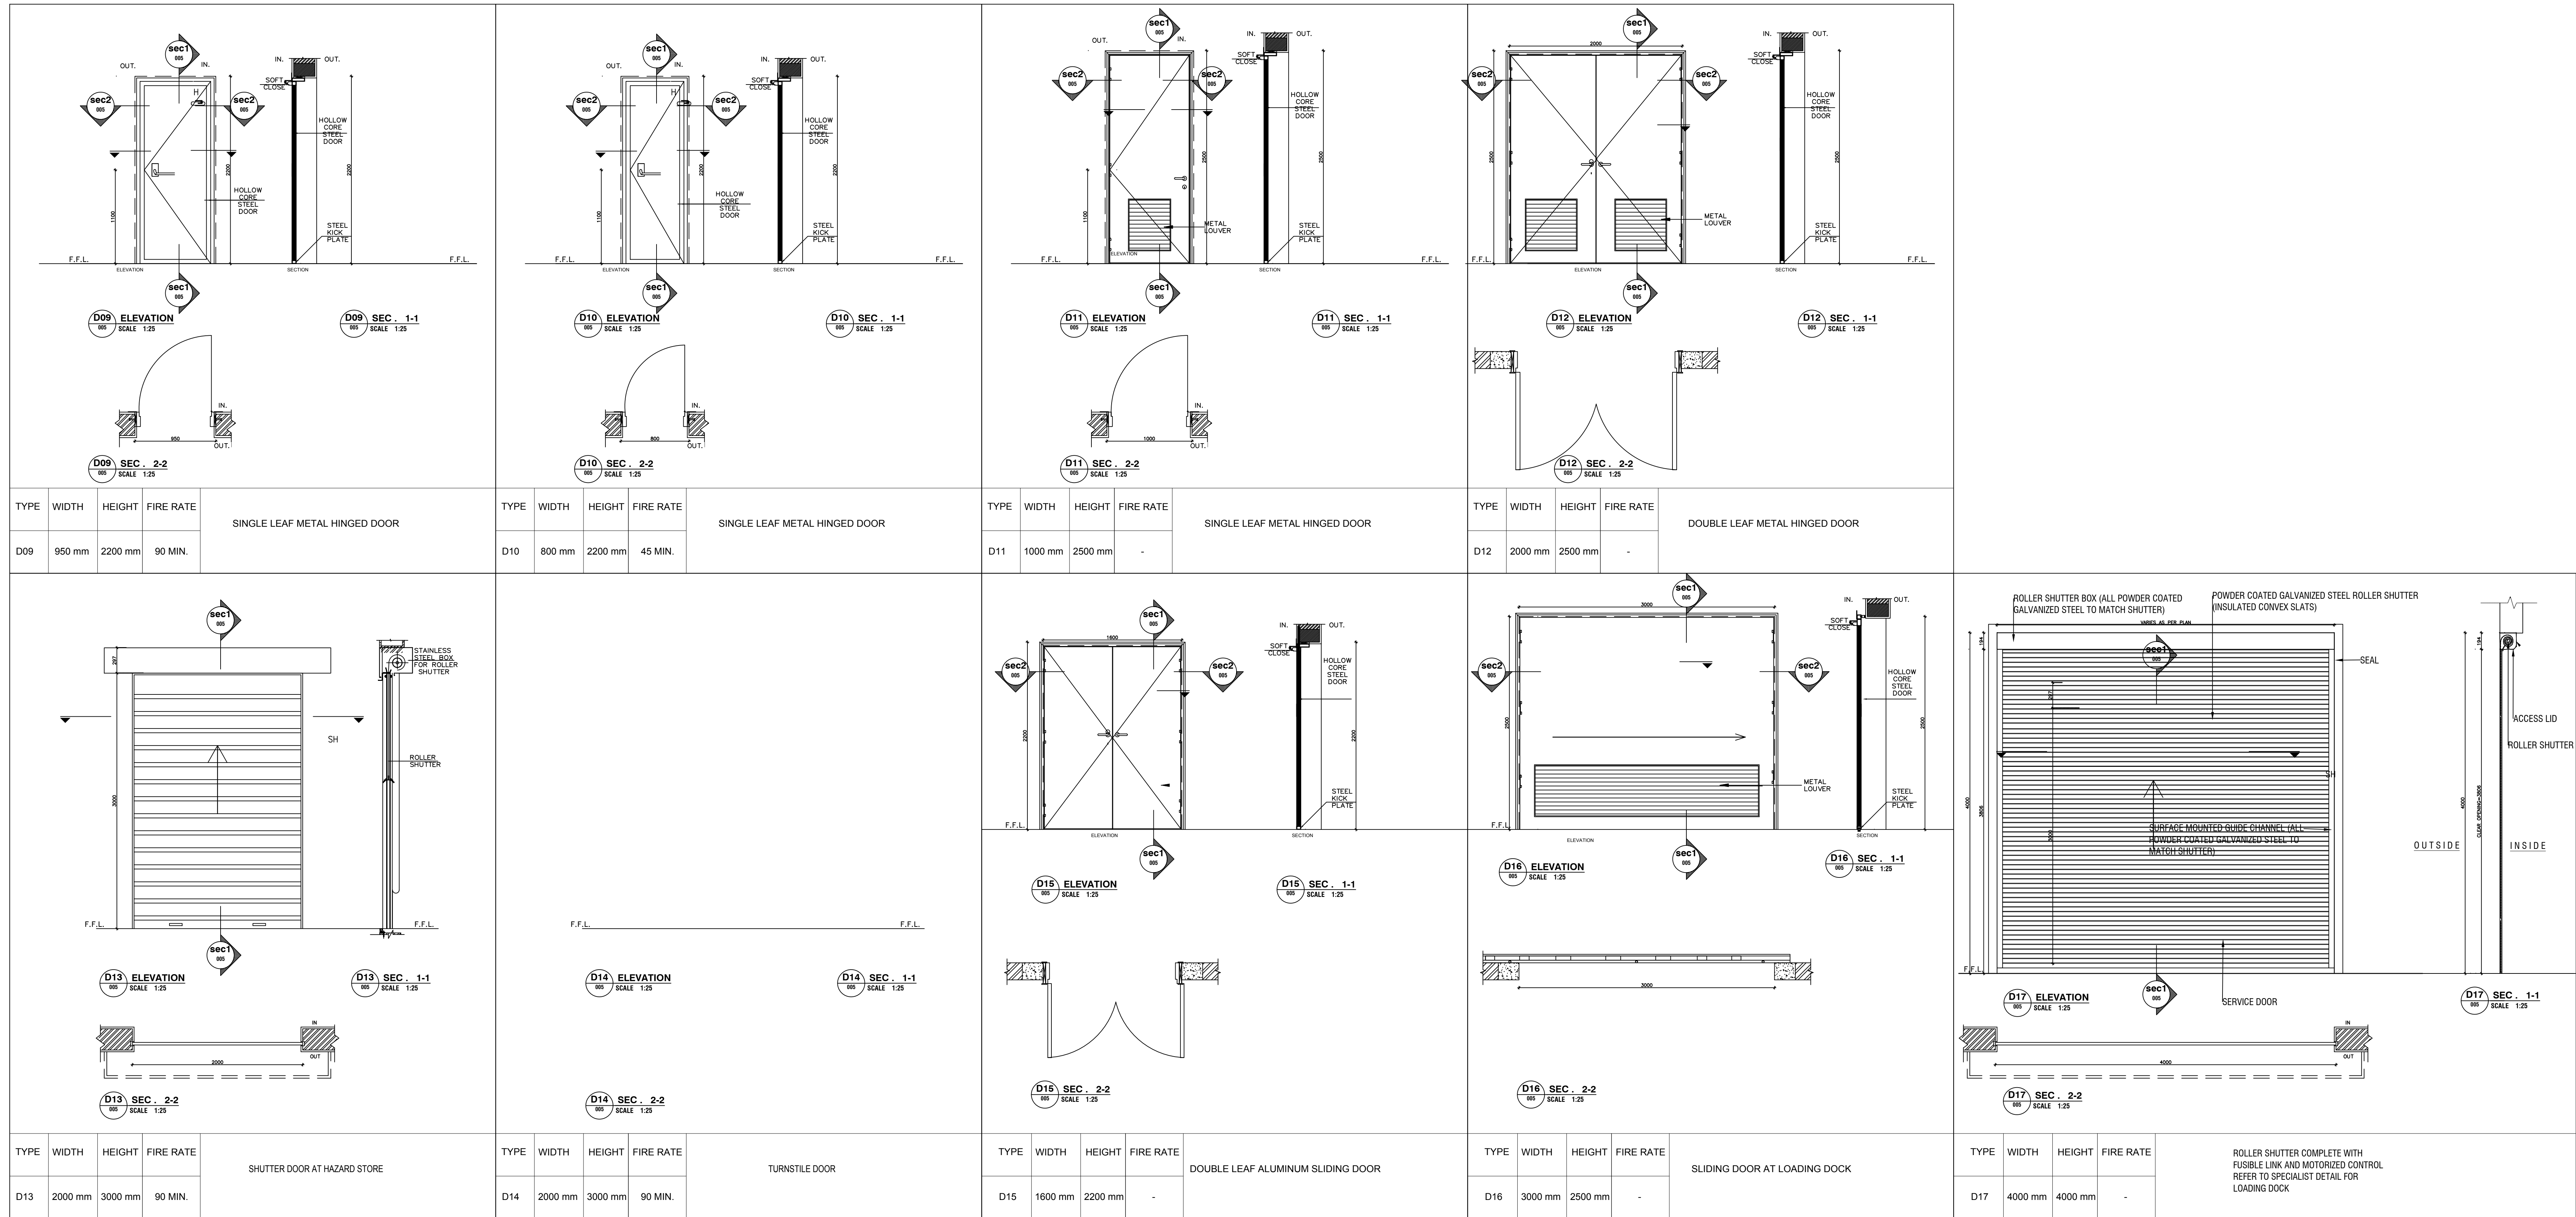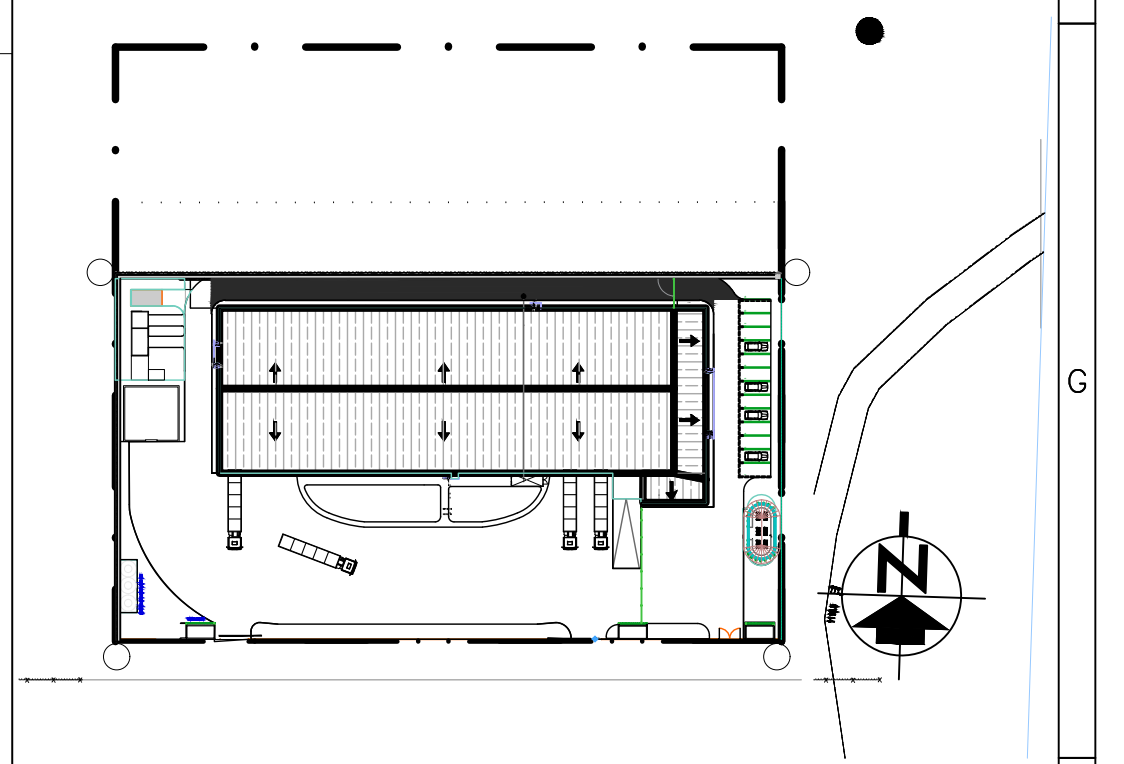
$$\pm 0.00 = 1125.135$$


R6							
R5							
R4							
R3							
R2							
R1	16-07-20	ISSUED FOR 50% DESIGN DEVELOPMENT			A.YASSER	H.ASEER	M.ASEER
INDEX	DATE	DESCRIPTION			DESIGNED BY	CHECKED BY	APPROVED BY
THIS DRAWING IS THE PROPERTY OF COSMOS-E AND MUST NOT BE REPRODUCED OR ITS CONTENTS DIAVALGED WITHOUT WRITTEN PERMISSION							

CLIENT



MAIN CONSULTANT



COSMOS-E

Dr. El. MOLTAKA EL. ARABY DISTRICT
ASAWEN GHARATON, HELIOPOLIS,
ARAD, EGYPT.
E-MAIL: 222697780-20644303/30
E-MAIL: 222697782 P-CODE: 11361
E-MAIL: info@araby-eng.com

LOCAL CONSULTANT



PROJECT TITLE
ZIMBABWE (MUTARE) MEDICAL WAREHOUSE PROJECT

DRAWING TITLE

DOOR TYPES

PROJECT NO. Z2016	SCALE: 1:25
----------------------	----------------

DRAWING NO.

Z	2	0	1	6
---	---	---	---	---

 -

0	0	0
---	---	---

 -

A	D	E
---	---	---

 -

0	0	6
---	---	---


 -

0	0
---	---


 -

0

PROJECT NUMBER BUILDING NO. DOC. DESCRIPTION DOC. NUMBER PARTS REV.

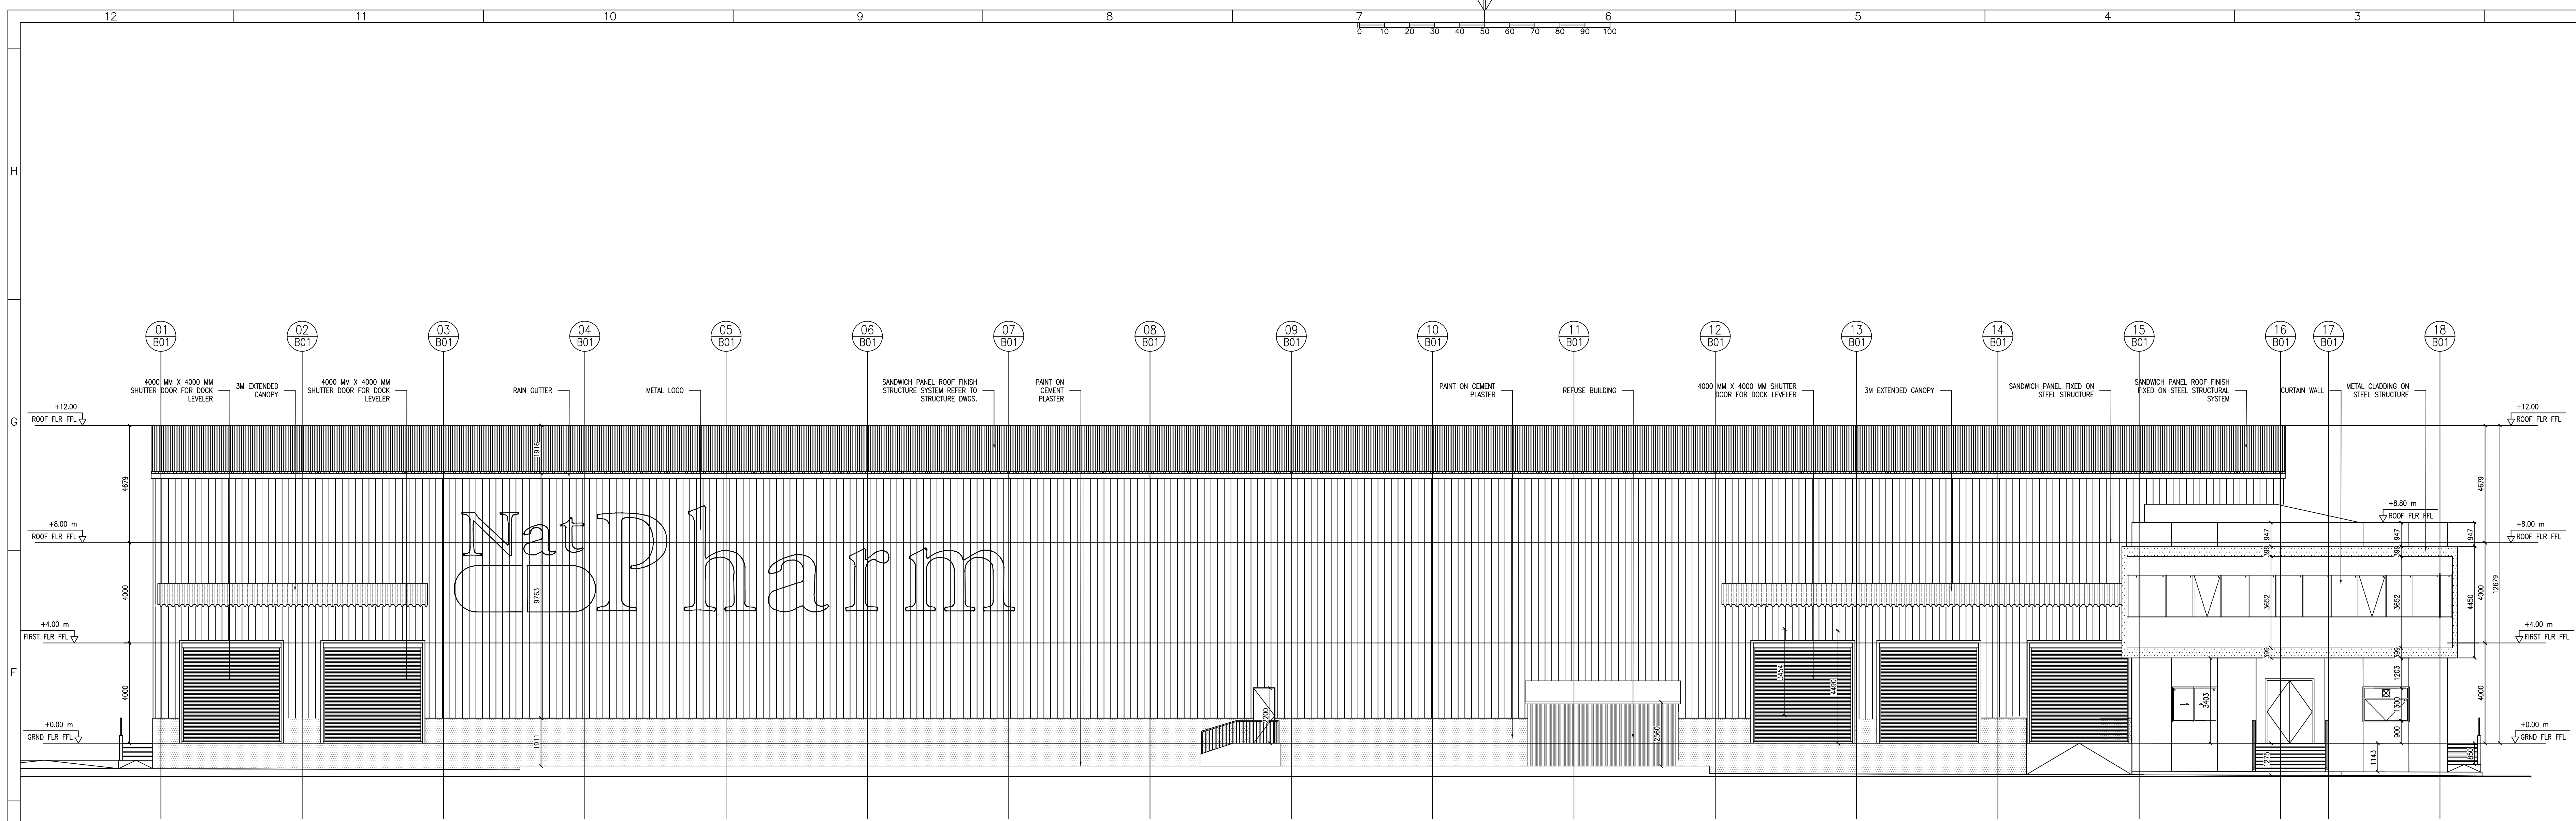


1 ELEVATION A
SCALE 1:100

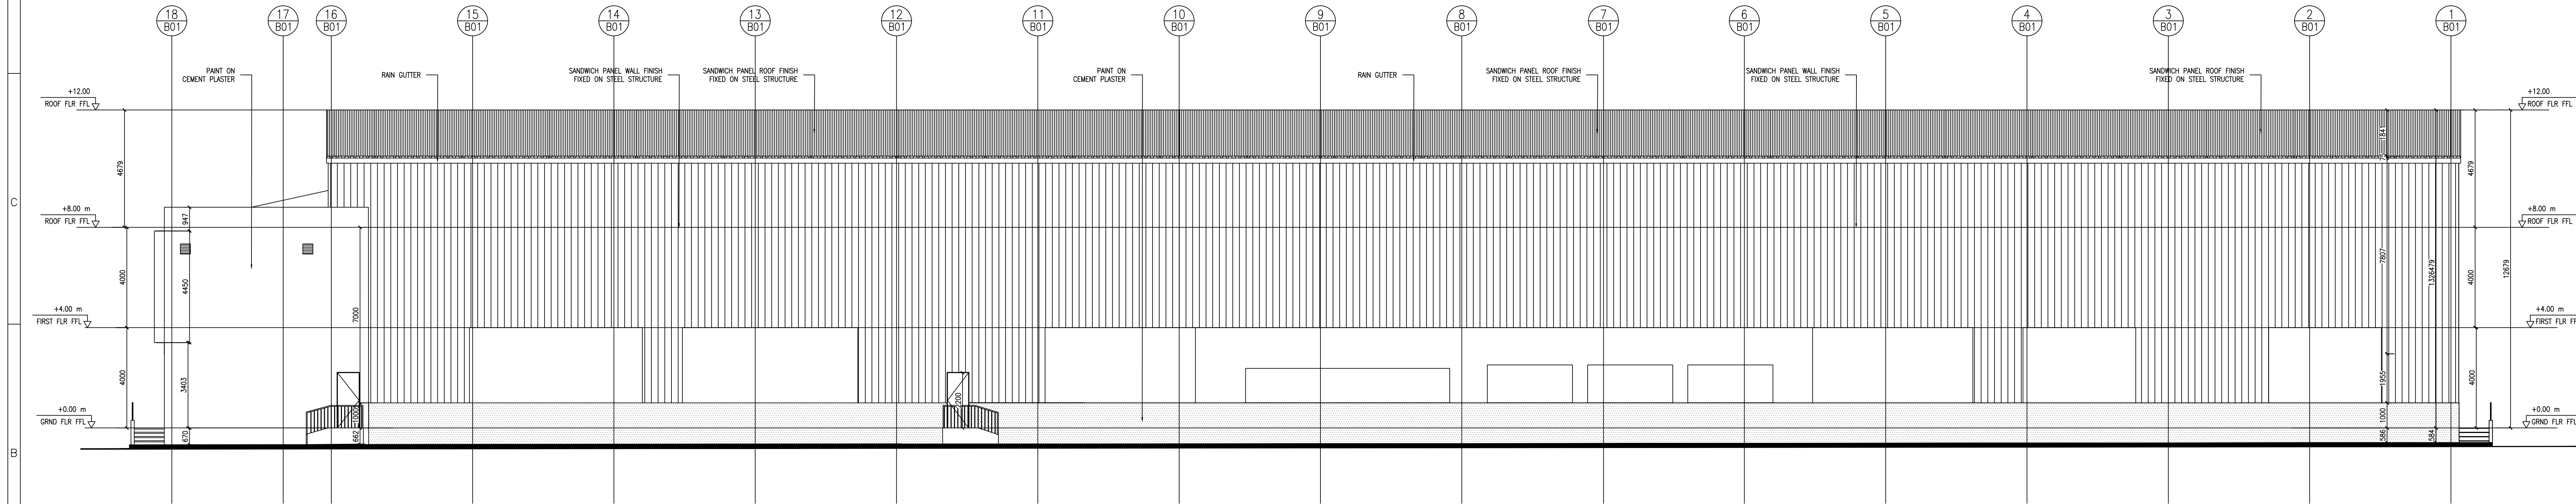


1 ELEVATION B
SCALE 1:100

- 1- DO NOT SCALE THIS DRAWINGS (DIMENSIONS SHOULD BE CALCULATED NEVER SCALED).
- 2- ALL DIMENSIONS ARE IN MILLIMETER UNLESS OTHERWISE INDICATED.
- 3- ALL LEVELS ARE IN METERS UNLESS OTHERWISE INDICATED.
- 4- THIS DWG. IS TO BE READ IN CONJUNCTION WITH ALL OTHER ARCHITECTURAL, STRUCTURAL, ELECTRICAL, MECHANICAL & S.O.D.
- 5- LEVELS ON ARCHITECTURAL DRAWINGS ARE FOR INFORMATION ONLY. THE FINISH FLOOR LEVEL (F.F.L) IN THE ARCHITECTURAL DRAWINGS IS THE BASIS OF ALL LEVELS IN ALL OTHER TRADES (STRUCTURAL, ELECTRICAL, MECHANICAL...)

±0.00= 1125.135

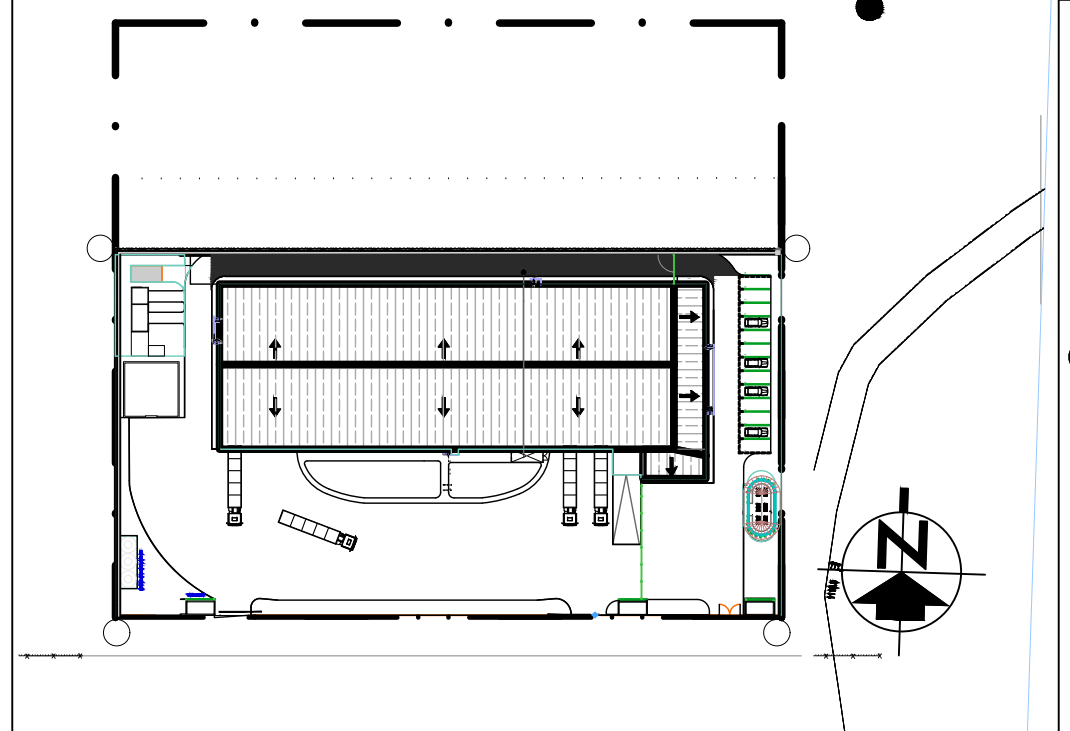


R01					
R02					
R03					
R390					

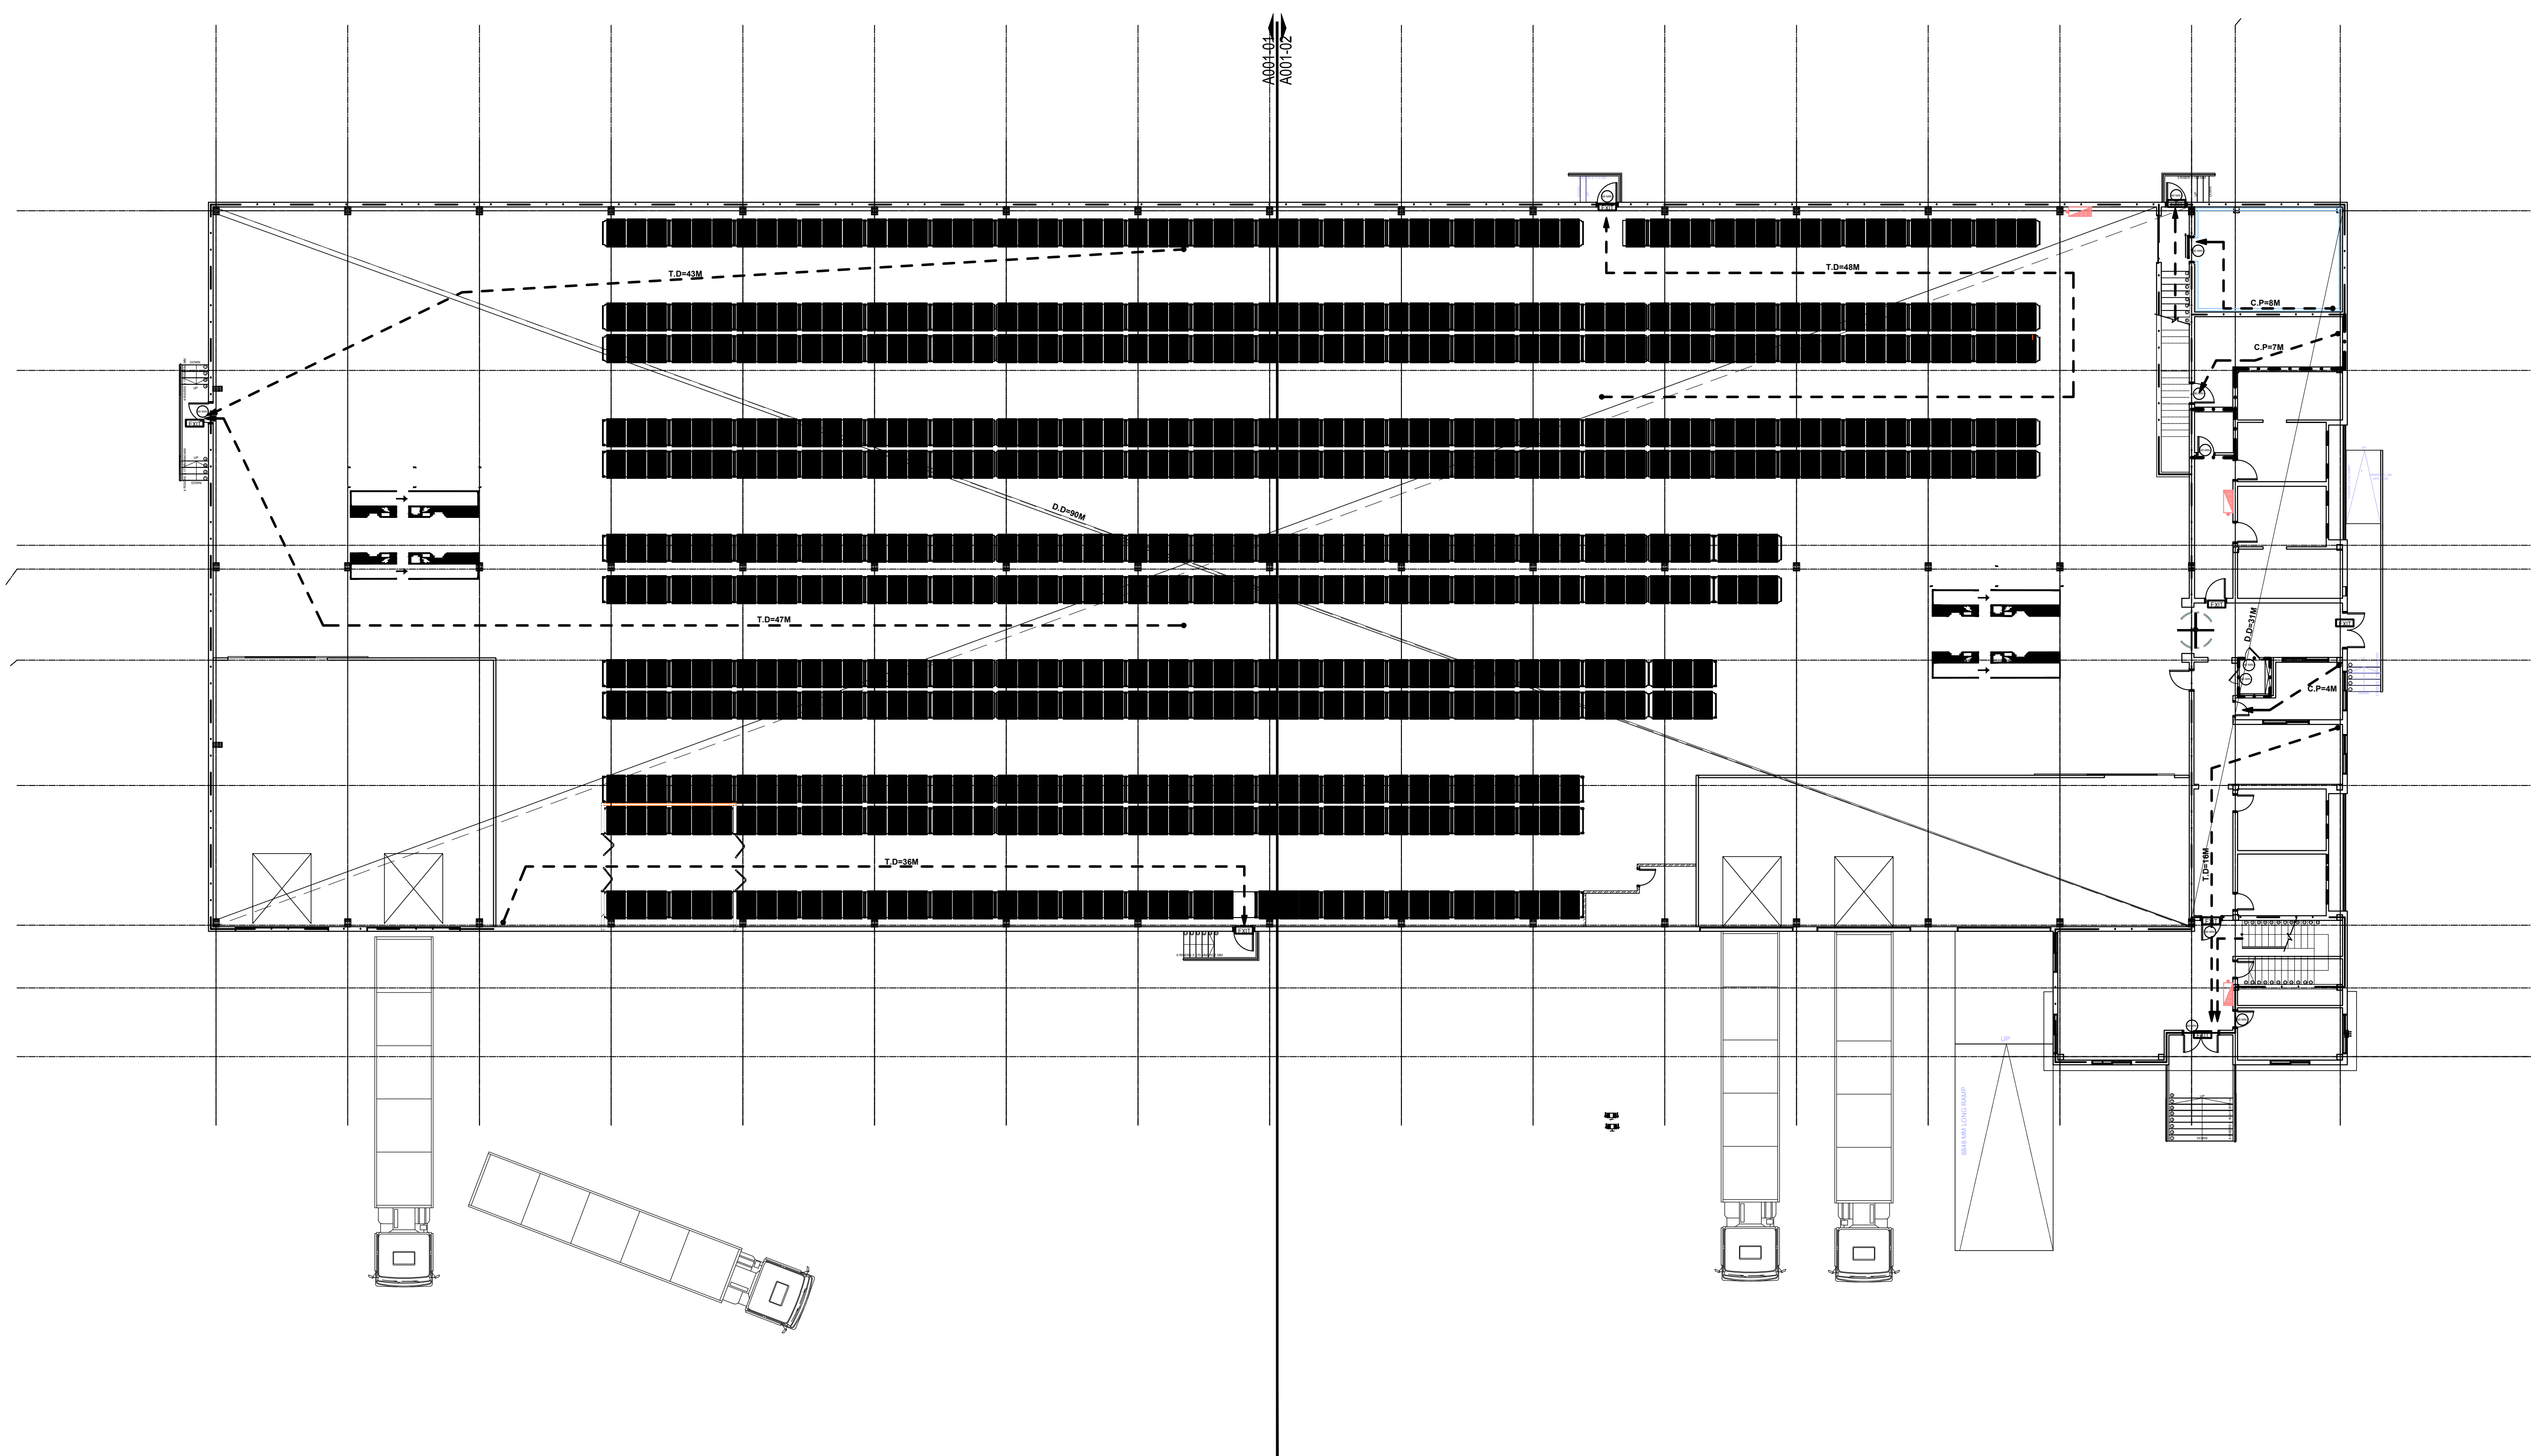

1 LIFE SAFETY WAREHOUSE GROUND FLOOR PLAN OVERALL
SCALE 1:150

1- DO NOT SCALE THIS DRAWINGS (DIMENSIONS SHOULD BE CALCULATED NEVER SCALED).
2- ALL DIMENSIONS ARE IN MILLIMETER UNLESS OTHERWISE INDICATED.
3- ALL LEVELS ARE IN METERS UNLESS OTHERWISE INDICATED.
4- THIS DWG. IS TO BE READ IN CONJUNCTION WITH ALL OTHER ARCHITECTURAL, STRUCTURAL, ELECTRICAL, MECHANICAL & S.D.O.
5- LEVELS ON ARCHITECTURAL DRAWINGS ARE FOR INFORMATION ONLY. THE FINISH FLOOR LEVEL (F.F.L) IN THE ARCHITECTURAL DRAWINGS IS THE BASIS OF ALL LEVELS IN ALL OTHER TRADES (STRUCTURAL, ELECTRICAL, MECHANICAL...)

±0.00= 1125.135

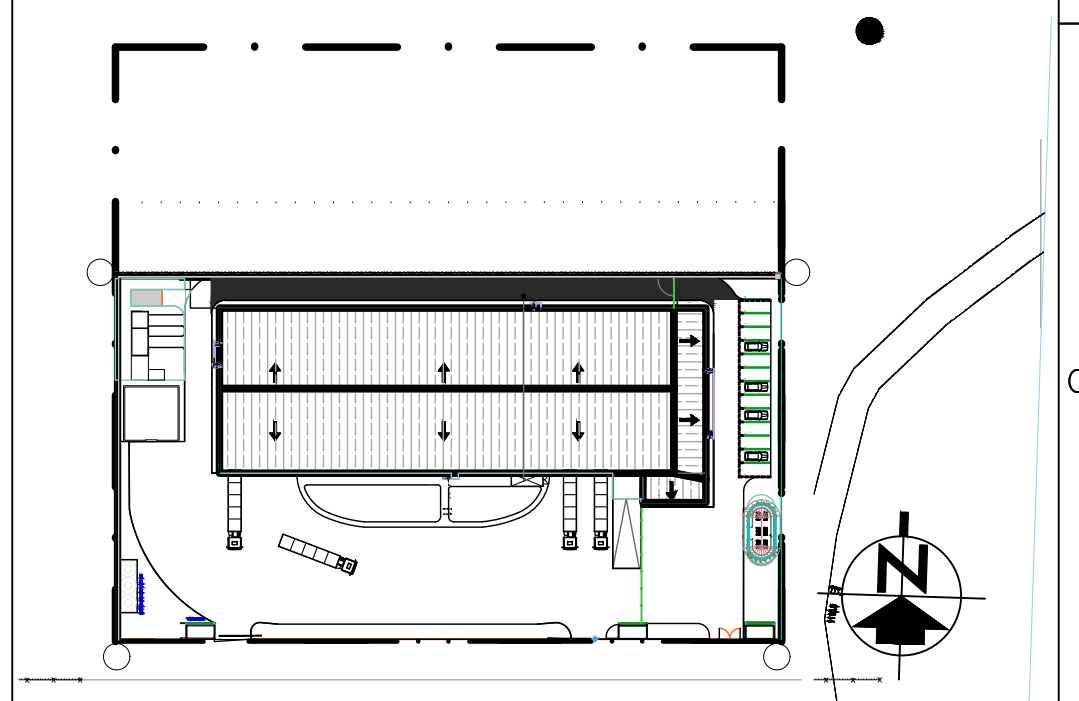

FIRE ESCAPE & PROTECTION SYSTEM LEGEND	
---	FIRE RATING WALL 2-HOURS
---	FIRE RATING WALL 1-HOUR
(90 MIN)	90 MINUTES FIRE RATED DOOR WITH SELF CLOSING LATCH
(45 MIN)	45 MINUTES FIRE RATED DOOR WITH SELF CLOSING LATCH
EXIT	DIRECTIONAL EXIT SIGN-ONE WAY
●	OVERALL TRAVEL DISTANCE
●---	TRAVEL DISTANCE WITHIN THE SPACE
---	DIAGONAL DISTANCE
●---	COMMON PATH WITHIN THE SPACE
---	SURFACE/SUSPENDED MOUNTED MAINTAINED
---	WALL MOUNTED MAINTAINED

R01					
R02					
R03					
R100					

THIS DRAWING IS THE PROPERTY OF COSMOS-E AND MUST NOT BE REPRODUCED OR ITS CONTENTS QUALIFIED WITHOUT WRITTEN PERMISSION




PROJECT TITLE
ZIMBABWE (MUTARE) MEDICAL
WAREHOUSE PROJECT

DRAWING TITLE
LIFE SAFETY WAREHOUSE GROUND FLOOR PLAN
OVERALL


PROJECT NO. Z2016 SCALE: 1:150

DRAWING NO. Z2016-010-A101-0112-010-01
PROJECT NUMBER BUILDING NO. DOC. DESCRIPTION DOC. NUMBER PARTS REV

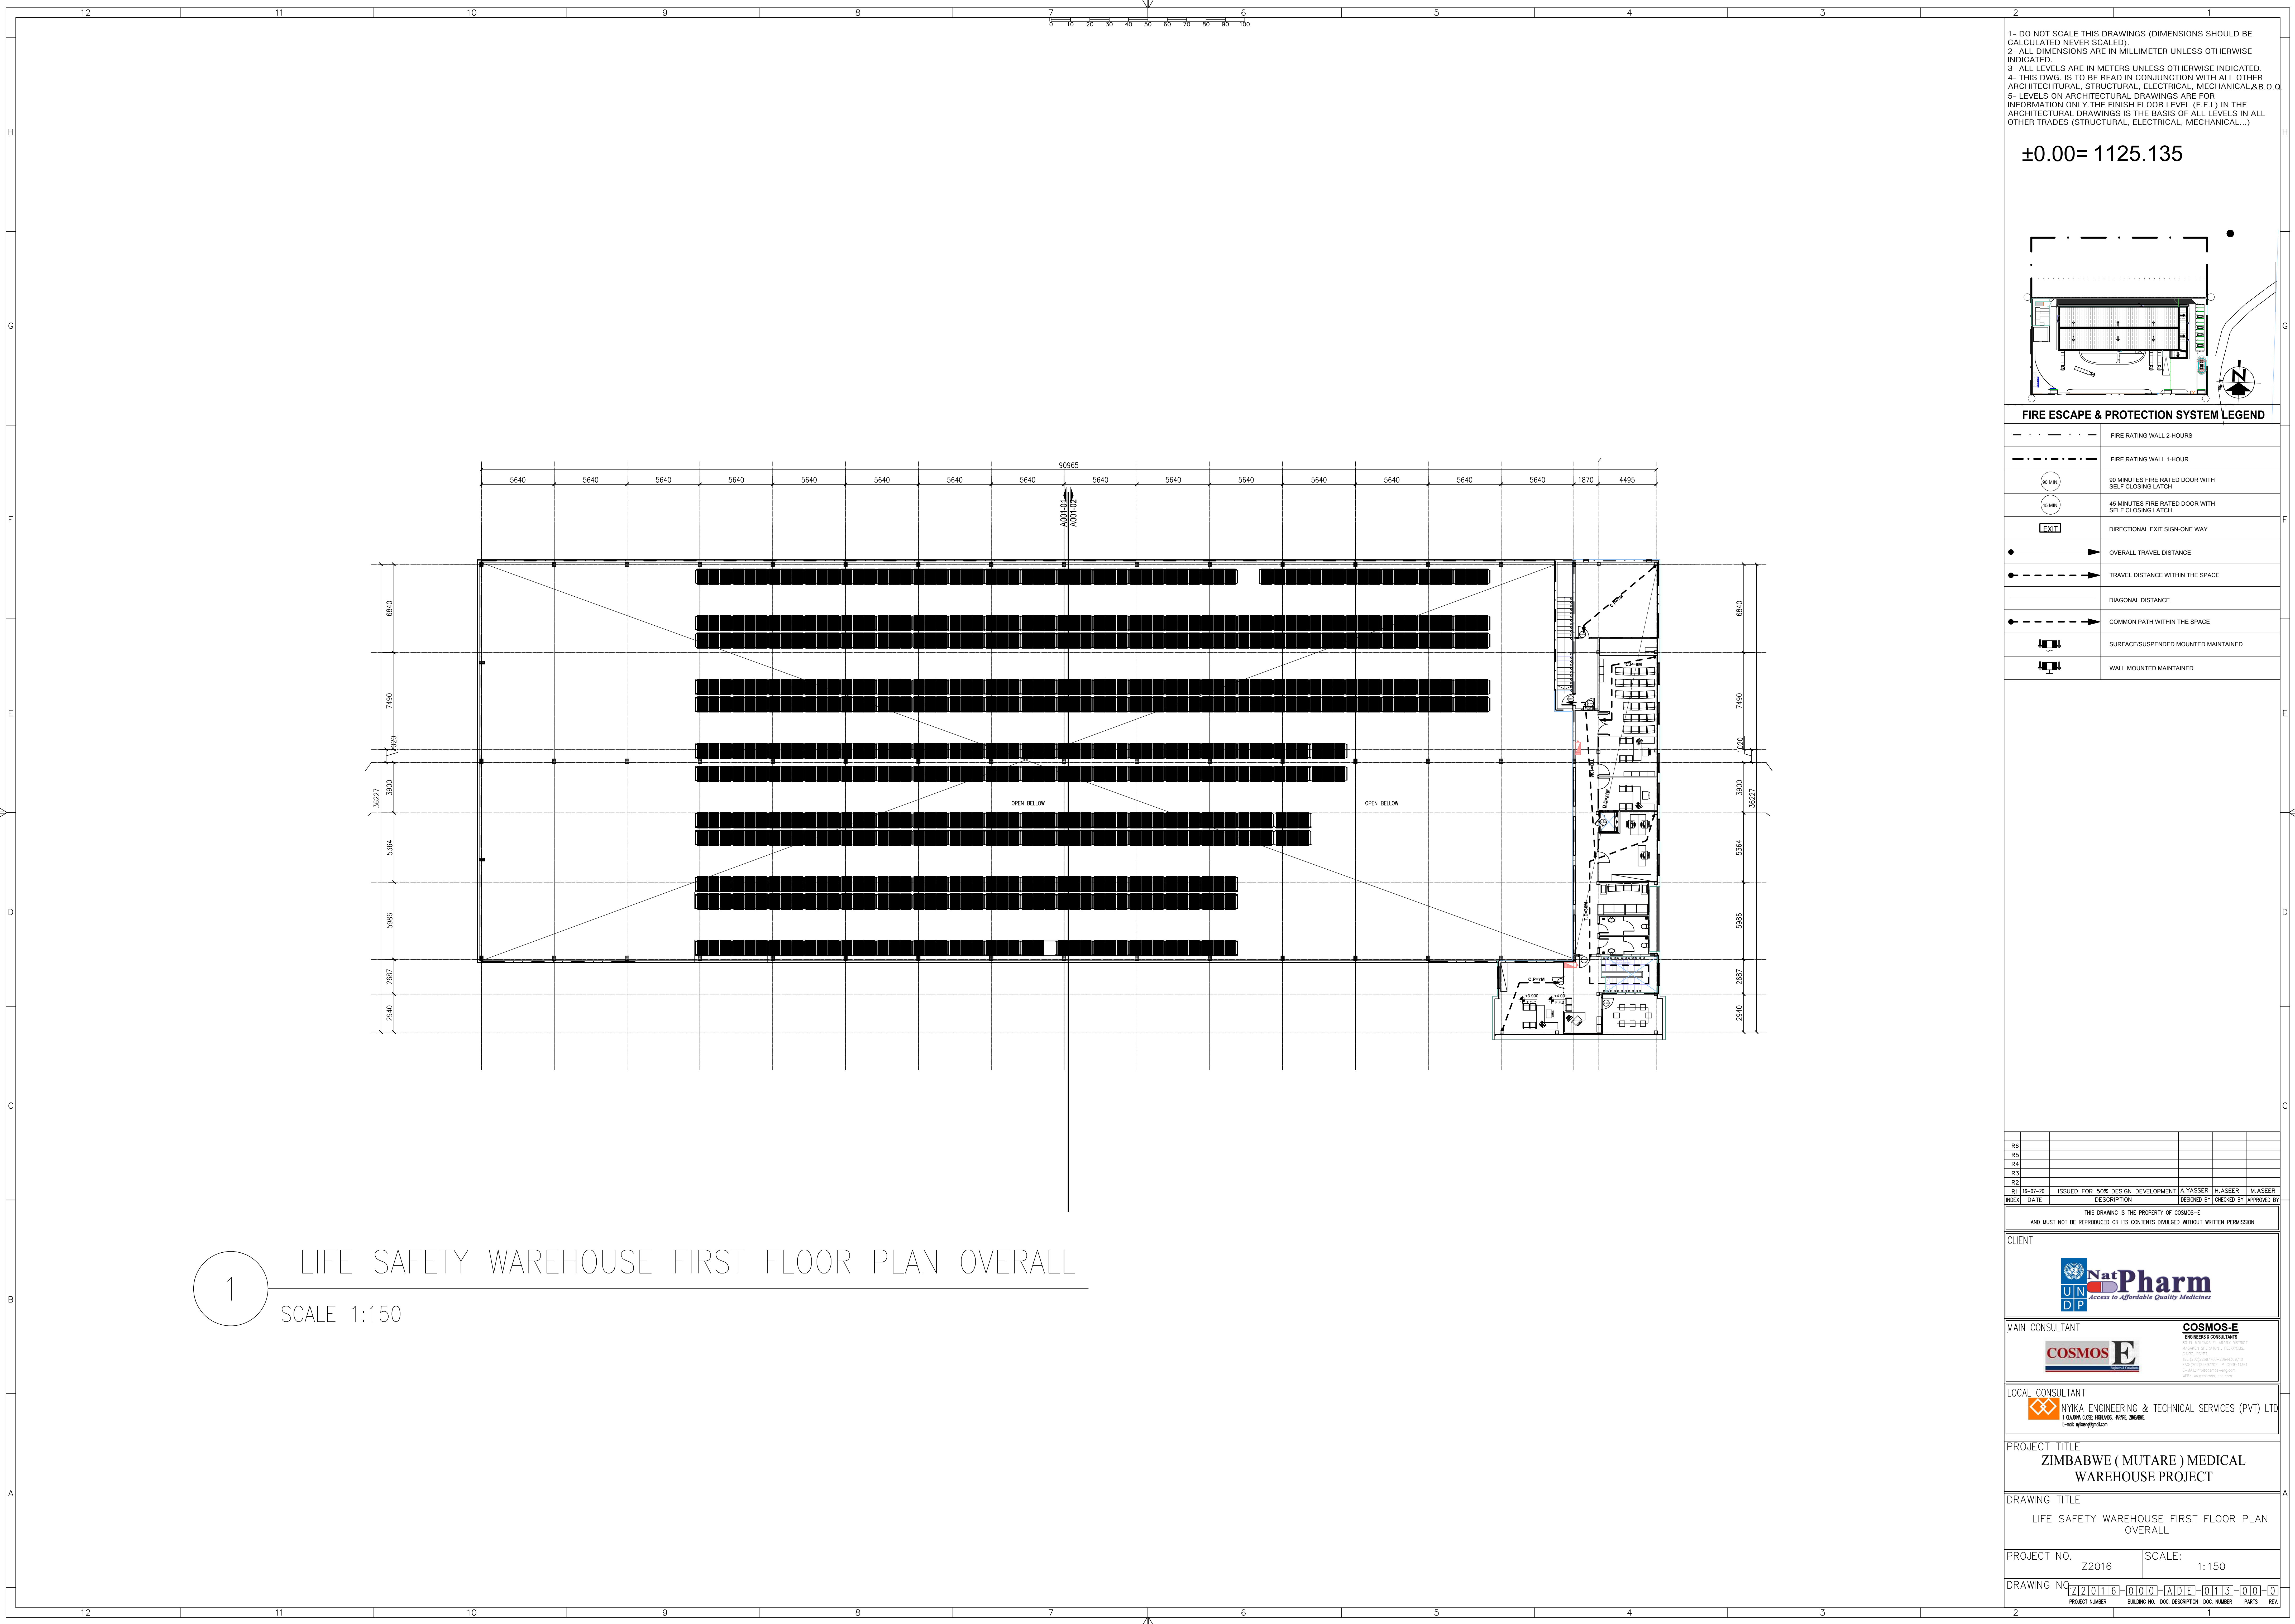

1- DO NOT SCALE THIS DRAWINGS (DIMENSIONS SHOULD BE CALCULATED NEVER SCALED).
2- ALL DIMENSIONS ARE IN MILLIMETER UNLESS OTHERWISE INDICATED.
3- ALL LEVELS ARE IN METERS UNLESS OTHERWISE INDICATED.
4- THIS DWG. IS TO BE READ IN CONJUNCTION WITH ALL OTHER ARCHITECTURAL, STRUCTURAL, ELECTRICAL, MECHANICAL & S.D.O.
5- LEVELS ON ARCHITECTURAL DRAWINGS ARE FOR INFORMATION ONLY. THE FINISH FLOOR LEVEL (F.F.L) IN THE ARCHITECTURAL DRAWINGS IS THE BASIS OF ALL LEVELS IN ALL OTHER TRADES (STRUCTURAL, ELECTRICAL, MECHANICAL...)

±0.00= 1125.135

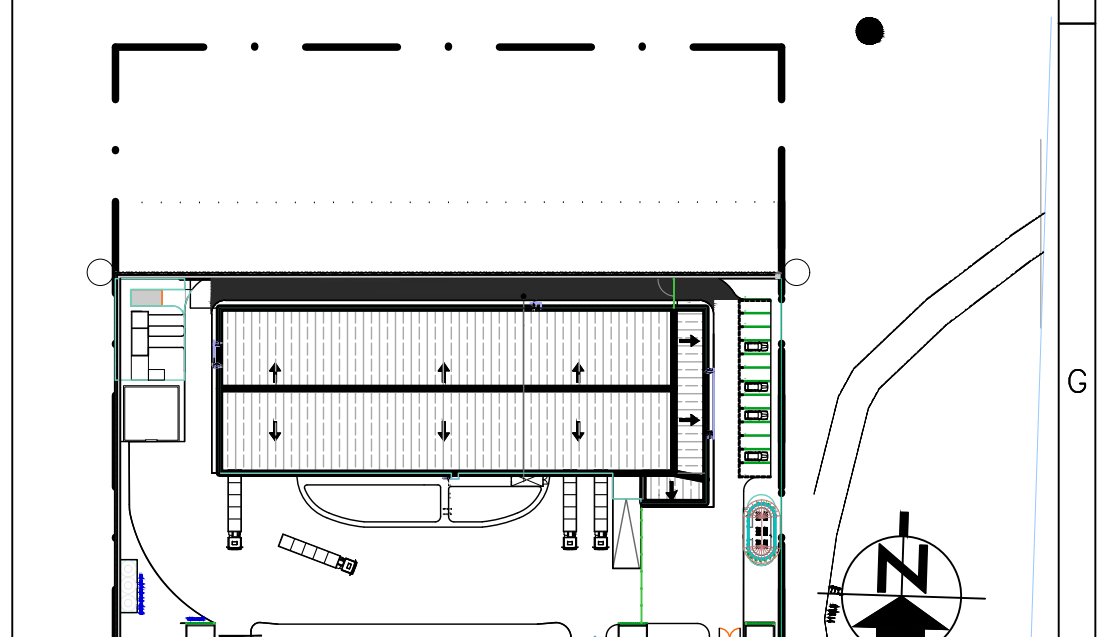

FIRE ESCAPE & PROTECTION SYSTEM LEGEND

---	FIRE RATING WALL 2-HOURS
- - - - -	FIRE RATING WALL 1-HOUR
(90 MIN)	90 MINUTES FIRE RATED DOOR WITH SELF CLOSING LATCH
(45 MIN)	45 MINUTES FIRE RATED DOOR WITH SELF CLOSING LATCH
EXIT	DIRECTIONAL EXIT SIGN ONE WAY
●	OVERALL TRAVEL DISTANCE
● - - - - -	TRAVEL DISTANCE WITHIN THE SPACE
---	DIAGONAL DISTANCE
● - - - - -	COMMON PATH WITHIN THE SPACE
---	SURFACE/SUSPENDED MOUNTED MAINTAINED
---	WALL MOUNTED MAINTAINED

R01					
R02					
R03					
R100					

THIS DRAWING IS THE PROPERTY OF COSMOS-E AND MUST NOT BE REPRODUCED OR ITS CONTENTS DIVULGED WITHOUT WRITTEN PERMISSION

CLIENT



PROJECT TITLE
ZIMBABWE (MUTARE) MEDICAL
WAREHOUSE PROJECT

DRAWING TITLE
LIFE SAFETY WAREHOUSE FIRST FLOOR PLAN
OVERALL

PROJECT NO. Z2016 SCALE: 1:150

DRAWING NO. Z2016-0101-A101-0113-010-01
PROJECT NUMBER BUILDING NO. DOC. DESCRIPTION DOC. NUMBER PARTS REV