


- NOTES
- ALL DRAWINGS ARE IN MILLIMETERS. ALL DIMENSIONS TO BE VERIFIED ON SITE AND APPROVED BY THE ENGINEER.
 - THIS DRAWING SHOULD BE READ IN CONTINUATION WITH OTHER RELEVANT ARCHITECTURAL, MECHANICAL/ELECTRICAL AND SPECIAL SYSTEMS DRAWINGS AND ALL RELEVANT SECTIONS OF THE SPECIFICATIONS.
 - CONTRACTOR SHALL CHECK AND COORDINATE ALL ARCHITECTURAL, STRUCTURAL, ELECTROMECHANICAL AND LANDSCAPE WORKS BEFORE CONSTRUCTION.

SYMBOLS/LEGEND:

- T/A TO ABOVE
F/A FROM ABOVE
T/B TO BELOW
F/B FROM BELOW
SPK SPRINKLER
FP FIRE PUMP
FE FIRE EXTINGUISHER
D DRAIN PIPE
DN DOWN
FNC FIRE HOSE CABINET
FHR FIRE HOSE REEL
FH FIRE HYDRANT
SC SIAMSESE CONNECTION
LV LANDING VALVE
OS&T OPEN STEEL & YOLKE VALVE
FMZ25 CLEAN AGENT EXTINGUISHER
U/O UNDERGROUND
ZCV ZONE CONTROL VALVE
FV FIRE SEARCH
FHC FIRE HOES CABINET (65mm)
ESR SPRINKLER HEAD
UPRGHT SPRINKLER HEAD
PENDENT SPRINKLER HEAD
SIDE WALL SPRINKLER HEAD
SIAMSESE CONNECTION
FIRE HYDRANT
FIRE EXTINGUISHER DRY POWDER
FIRE EXTINGUISHER CO2
FIRE EXTINGUISHER FOAM
FV FIRE SEARCH
AUTOMATIC FIRE EXTINGUISHER

KEY PLAN

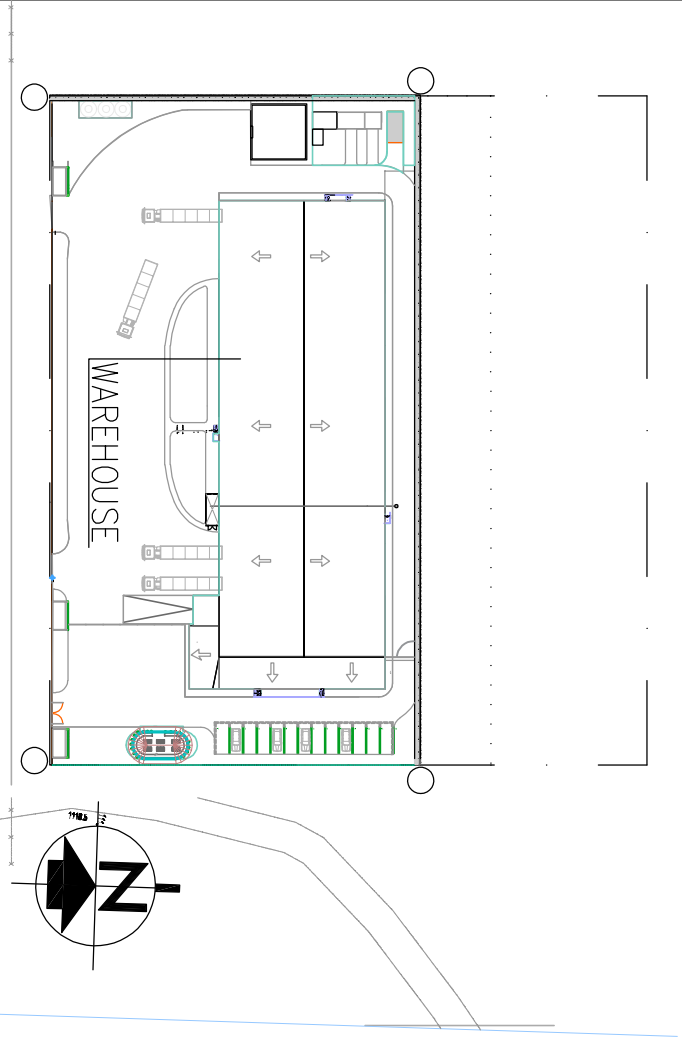

NO.	REVISION	DATE	DESCRIPTION	BY	CHKD	APPD
01	ISSUED FOR PERMIT	2016-03-20	ISSUED FOR PERMIT	...	...	...
02	ISSUED FOR PERMIT	2016-03-20	ISSUED FOR PERMIT	...	...	...
03	ISSUED FOR PERMIT	2016-03-20	ISSUED FOR PERMIT	...	...	...
04	ISSUED FOR PERMIT	2016-03-20	ISSUED FOR PERMIT	...	...	...
05	ISSUED FOR PERMIT	2016-03-20	ISSUED FOR PERMIT	...	...	...
06	ISSUED FOR PERMIT	2016-03-20	ISSUED FOR PERMIT	...	...	...
07	ISSUED FOR PERMIT	2016-03-20	ISSUED FOR PERMIT	...	...	...
08	ISSUED FOR PERMIT	2016-03-20	ISSUED FOR PERMIT	...	...	...
09	ISSUED FOR PERMIT	2016-03-20	ISSUED FOR PERMIT	...	...	...
10	ISSUED FOR PERMIT	2016-03-20	ISSUED FOR PERMIT	...	...	...

CLIENT



MAN CONSULTANT



LOCAL CONSULTANT
NINJA ENGINEERING & TECHNICAL SERVICES (PVT) LTD
100, 101, 102, 999, 1000

PROJECT TITLE
ZIMBABWE (MUTARE) MEDICAL
WAREHOUSE

DRAWING TITLE
FIRE FIGHTING SYSTEM
WAREHOUSE & ADMIN BUILDING
MEZZ. FLOOR PLAN

PROJECT NO. Z2016 SCALE: 1:125

DRAWING NO. Z2016-100-FDIE-102-00
PROJECT NAME: BUILDING NO. 002, DESIGNED BY: DR. MURRAY REV