



01 LAYOUT PLAN
Scale: 1:50

NOTE :

DEZAN
STUDIO

Bintaro Business Centre Building
Jl. RC Veteran No. 1-1 Bintaro
Phone: +62 21 7357679
Fax: +62 21 7433946
www.dezanstudio.com
admin@dezanstudio.com

CLIENT

UNDP

PROJECT

2019 - UNDP PROJECT 3A

DRAWING TITLE

LAYOUT PLAN

DRAWING No.	REVISION
INT-101	REV A
SCALE 1:50 @A3	CHECKED AS
DATE November 5, 2020	DRAWN AS



NOTE :

WORKSTATION

WS-1 : WORKSTATION TYPE - 1
WS-2 : WORKSTATION TYPE - 2

FILING CABINET

C-1 : FILING CABINET - 1
C-2 : FILING CABINET - 2
C-3 : FILING CABINET - 3
C-4 : FILING CABINET - 4
C-5 : PRINTING CABINET
C-6 : HANGING CABINET

JOINERIES

J-1 : MEETING TABLE
J-2 : DISCUSSION TABLE - 1
J-3 : DISCUSSION TABLE - 2
J-4 : PANTRY CABINET
J-5 : SOFA 1 SEATER
J-6 : SOFA BENCH
J-7 : BENCH
J-8A : QUIET ROOM TABLE - 1
J-8B : QUIET ROOM TABLE - 2
J-9 : DIVIDER
J-10 : PANEL WALL MEETING ROOM 1
J-11 : PANEL WALL MEETING ROOM 2
J-12 : COMMUNICATION WALL

LOOSE FURNITURE

F-1 : STAFF CHAIR
F-2 : MEETING CHAIR - 1
F-3 : MEETING CHAIR - 2
F-4 : DISCUSSION CHAIR
F-5 : BAR STOOL QUIET ROOM
F-6 : BAR STOOL PANTRY
F-7 : COFFEE TABLE

Bintaro Business Centre Building
Jl. RC Veteran No. 1-1 Bintaro
Phone: +62 21 7357679
Fax: +62 21 7433946
www.dezanstudio.com
admin@dezanstudio.com

CLIENT

UNDP


PROJECT

2019 - UNDP PROJECT 3A

DRAWING TITLE

FURNITURE PLAN

DRAWING No.	REVISION
INT-102	REV A
SCALE 1:50 @A3	CHECKED AS
DATE November 5, 2020	DRAWN AS

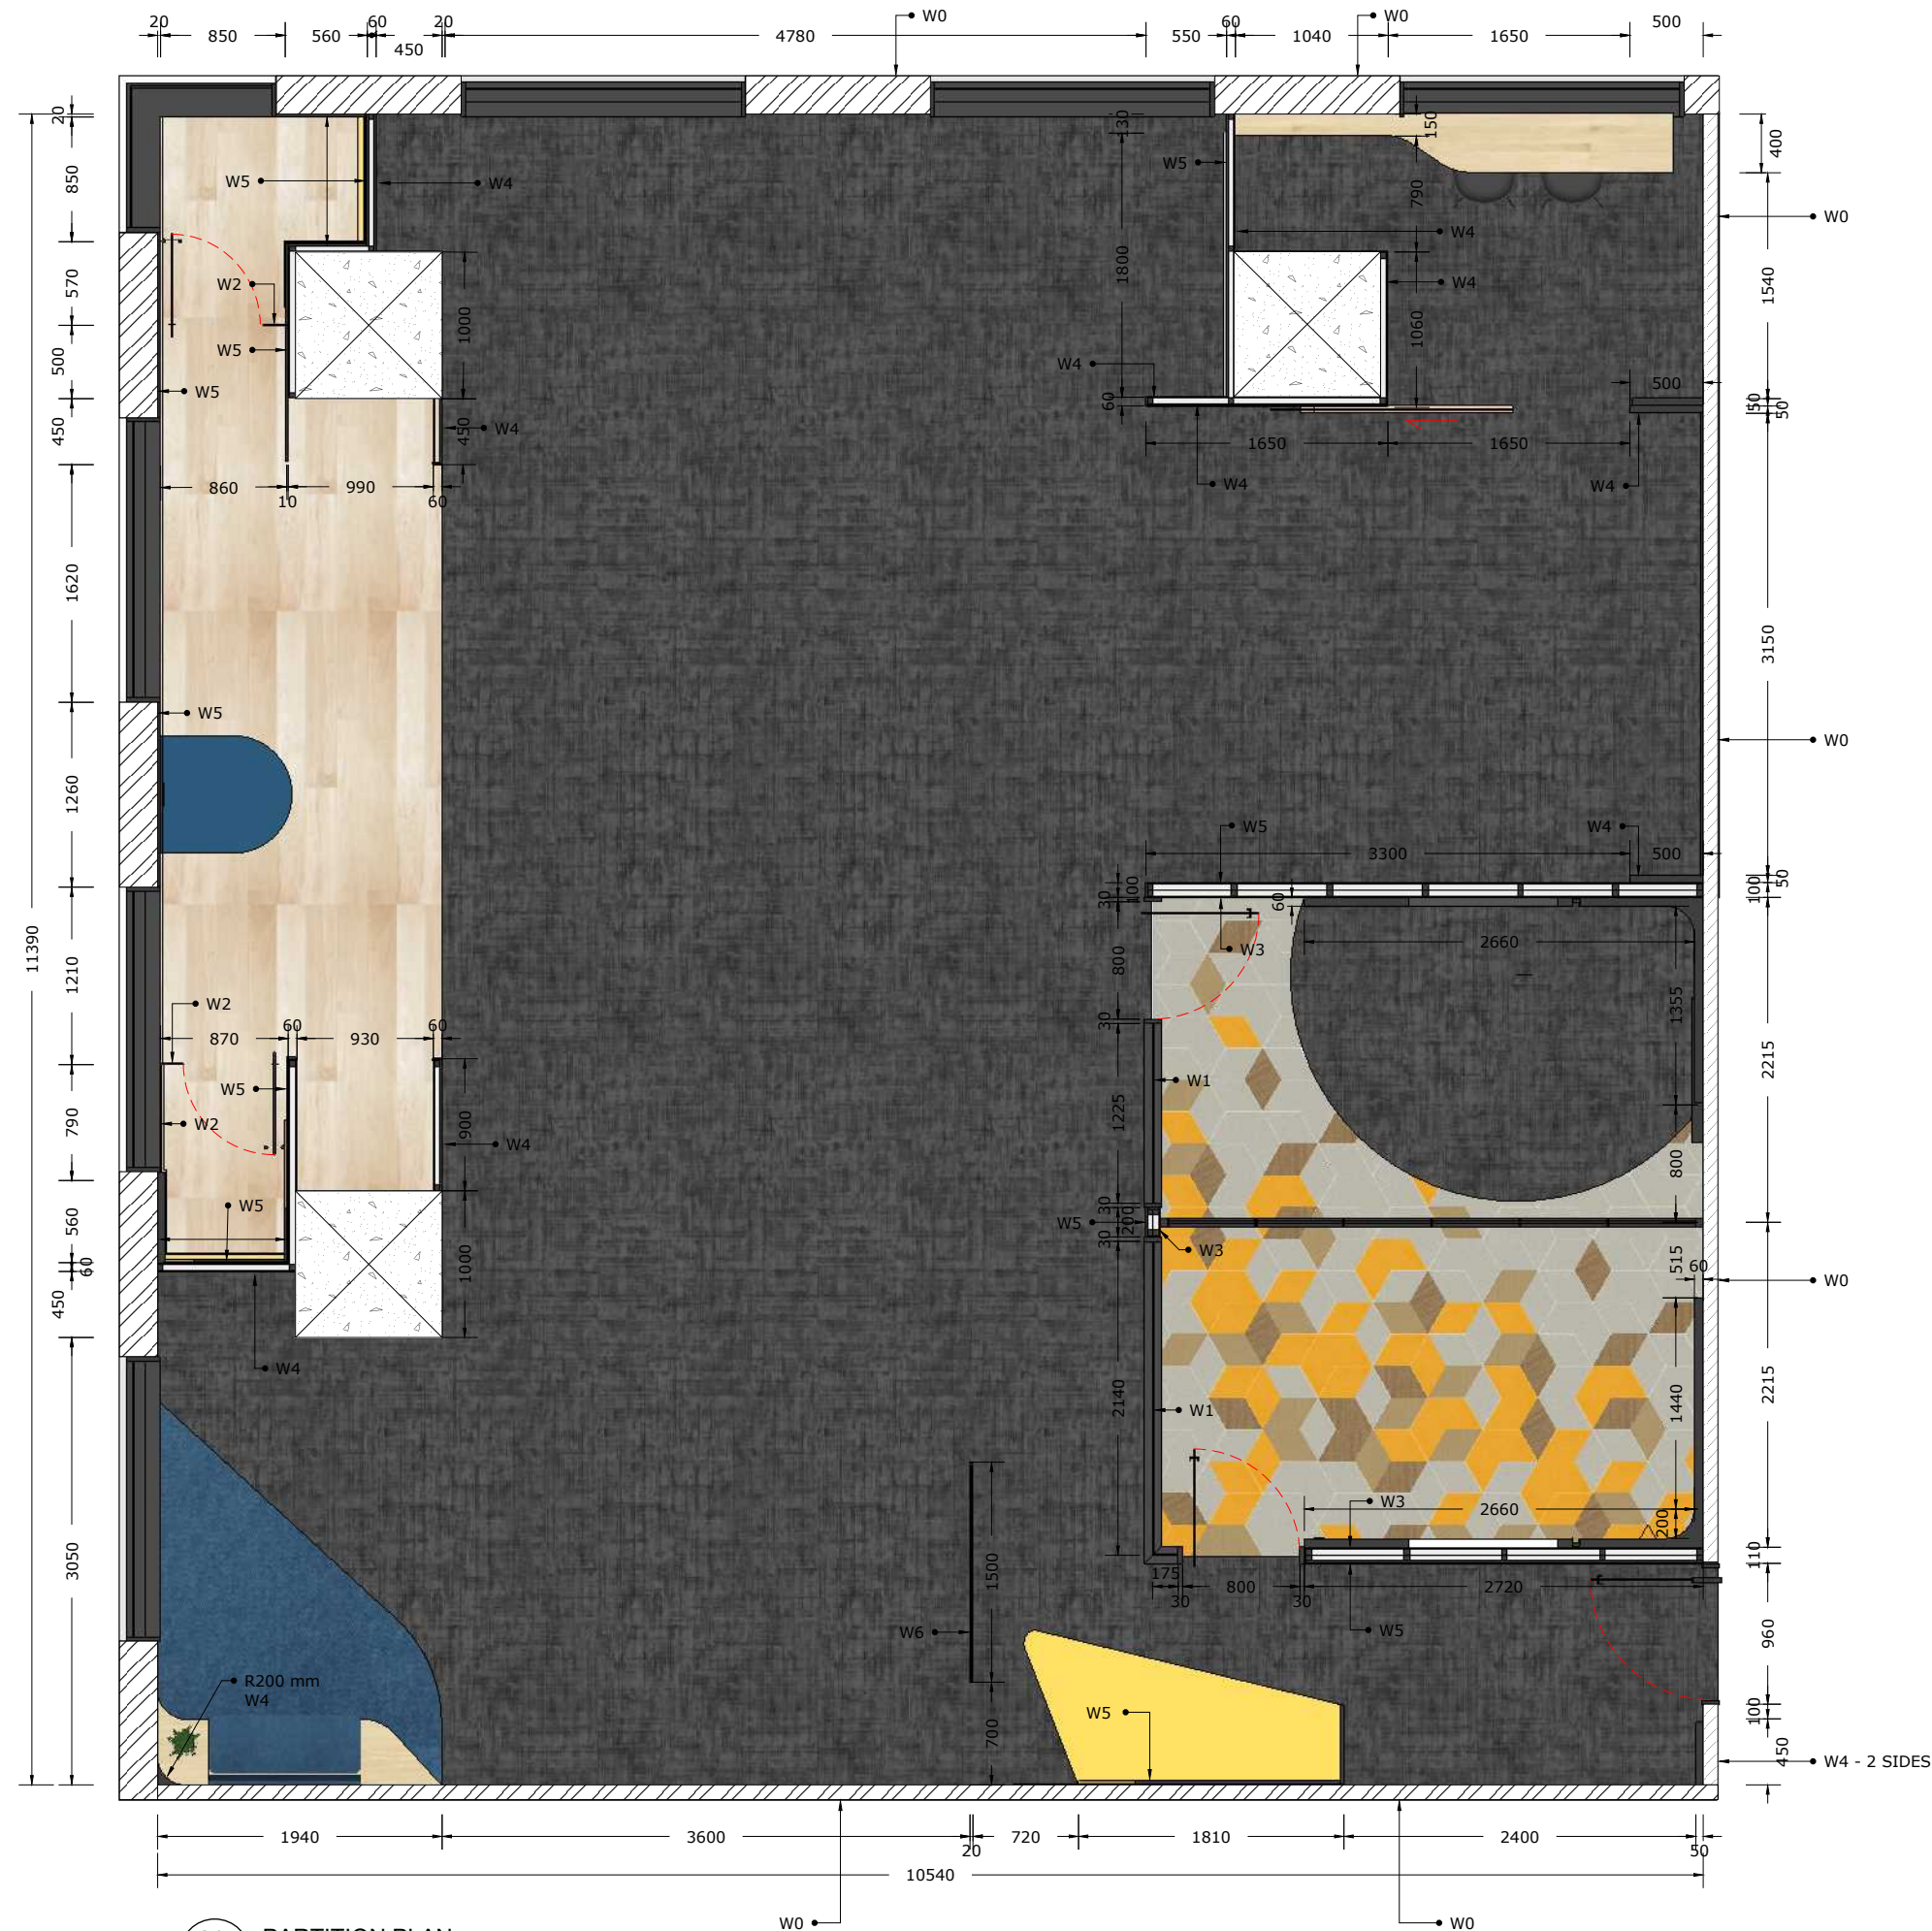

NOTE :

- W0 : EXISTING WALL
- W1 : TEMPERED GLASS 10 MM THK W/ FRAME (SIZE 3"), UP TO CEILING
- W2 : TEMPERED GLASS 12 MM THK FRAMELESS, UP TO CEILING
- W3 : GYPSUM PARTITION SOUNDPROFF W/ ROCKWOOL, UP TO CEILING
- W4 : GYPSUM PARTITION, SHEETROCK, UP TO CEILING
- W5 : PLYWOOD PARTITION, UP TO CEILING
- W6 : PERFORATED METAL + METAL FRAME 20 X 20 + PLYWOOD

Bintaro Business Centre Building
Jl. RC Veteran No. 1-1 Bintaro
Phone: +62 21 7357679
Fax: +62 21 7433946
www.dezanstudio.com
admin@dezanstudio.com

CLIENT

UNDP


PROJECT

2019 - UNDP PROJECT 3A

DRAWING TITLE

PARTITION PLAN

DRAWING No.	REVISION
INT-103	REV A
SCALE 1:50 @A3	CHECKED AS
DATE November 5, 2020	DRAWN AS

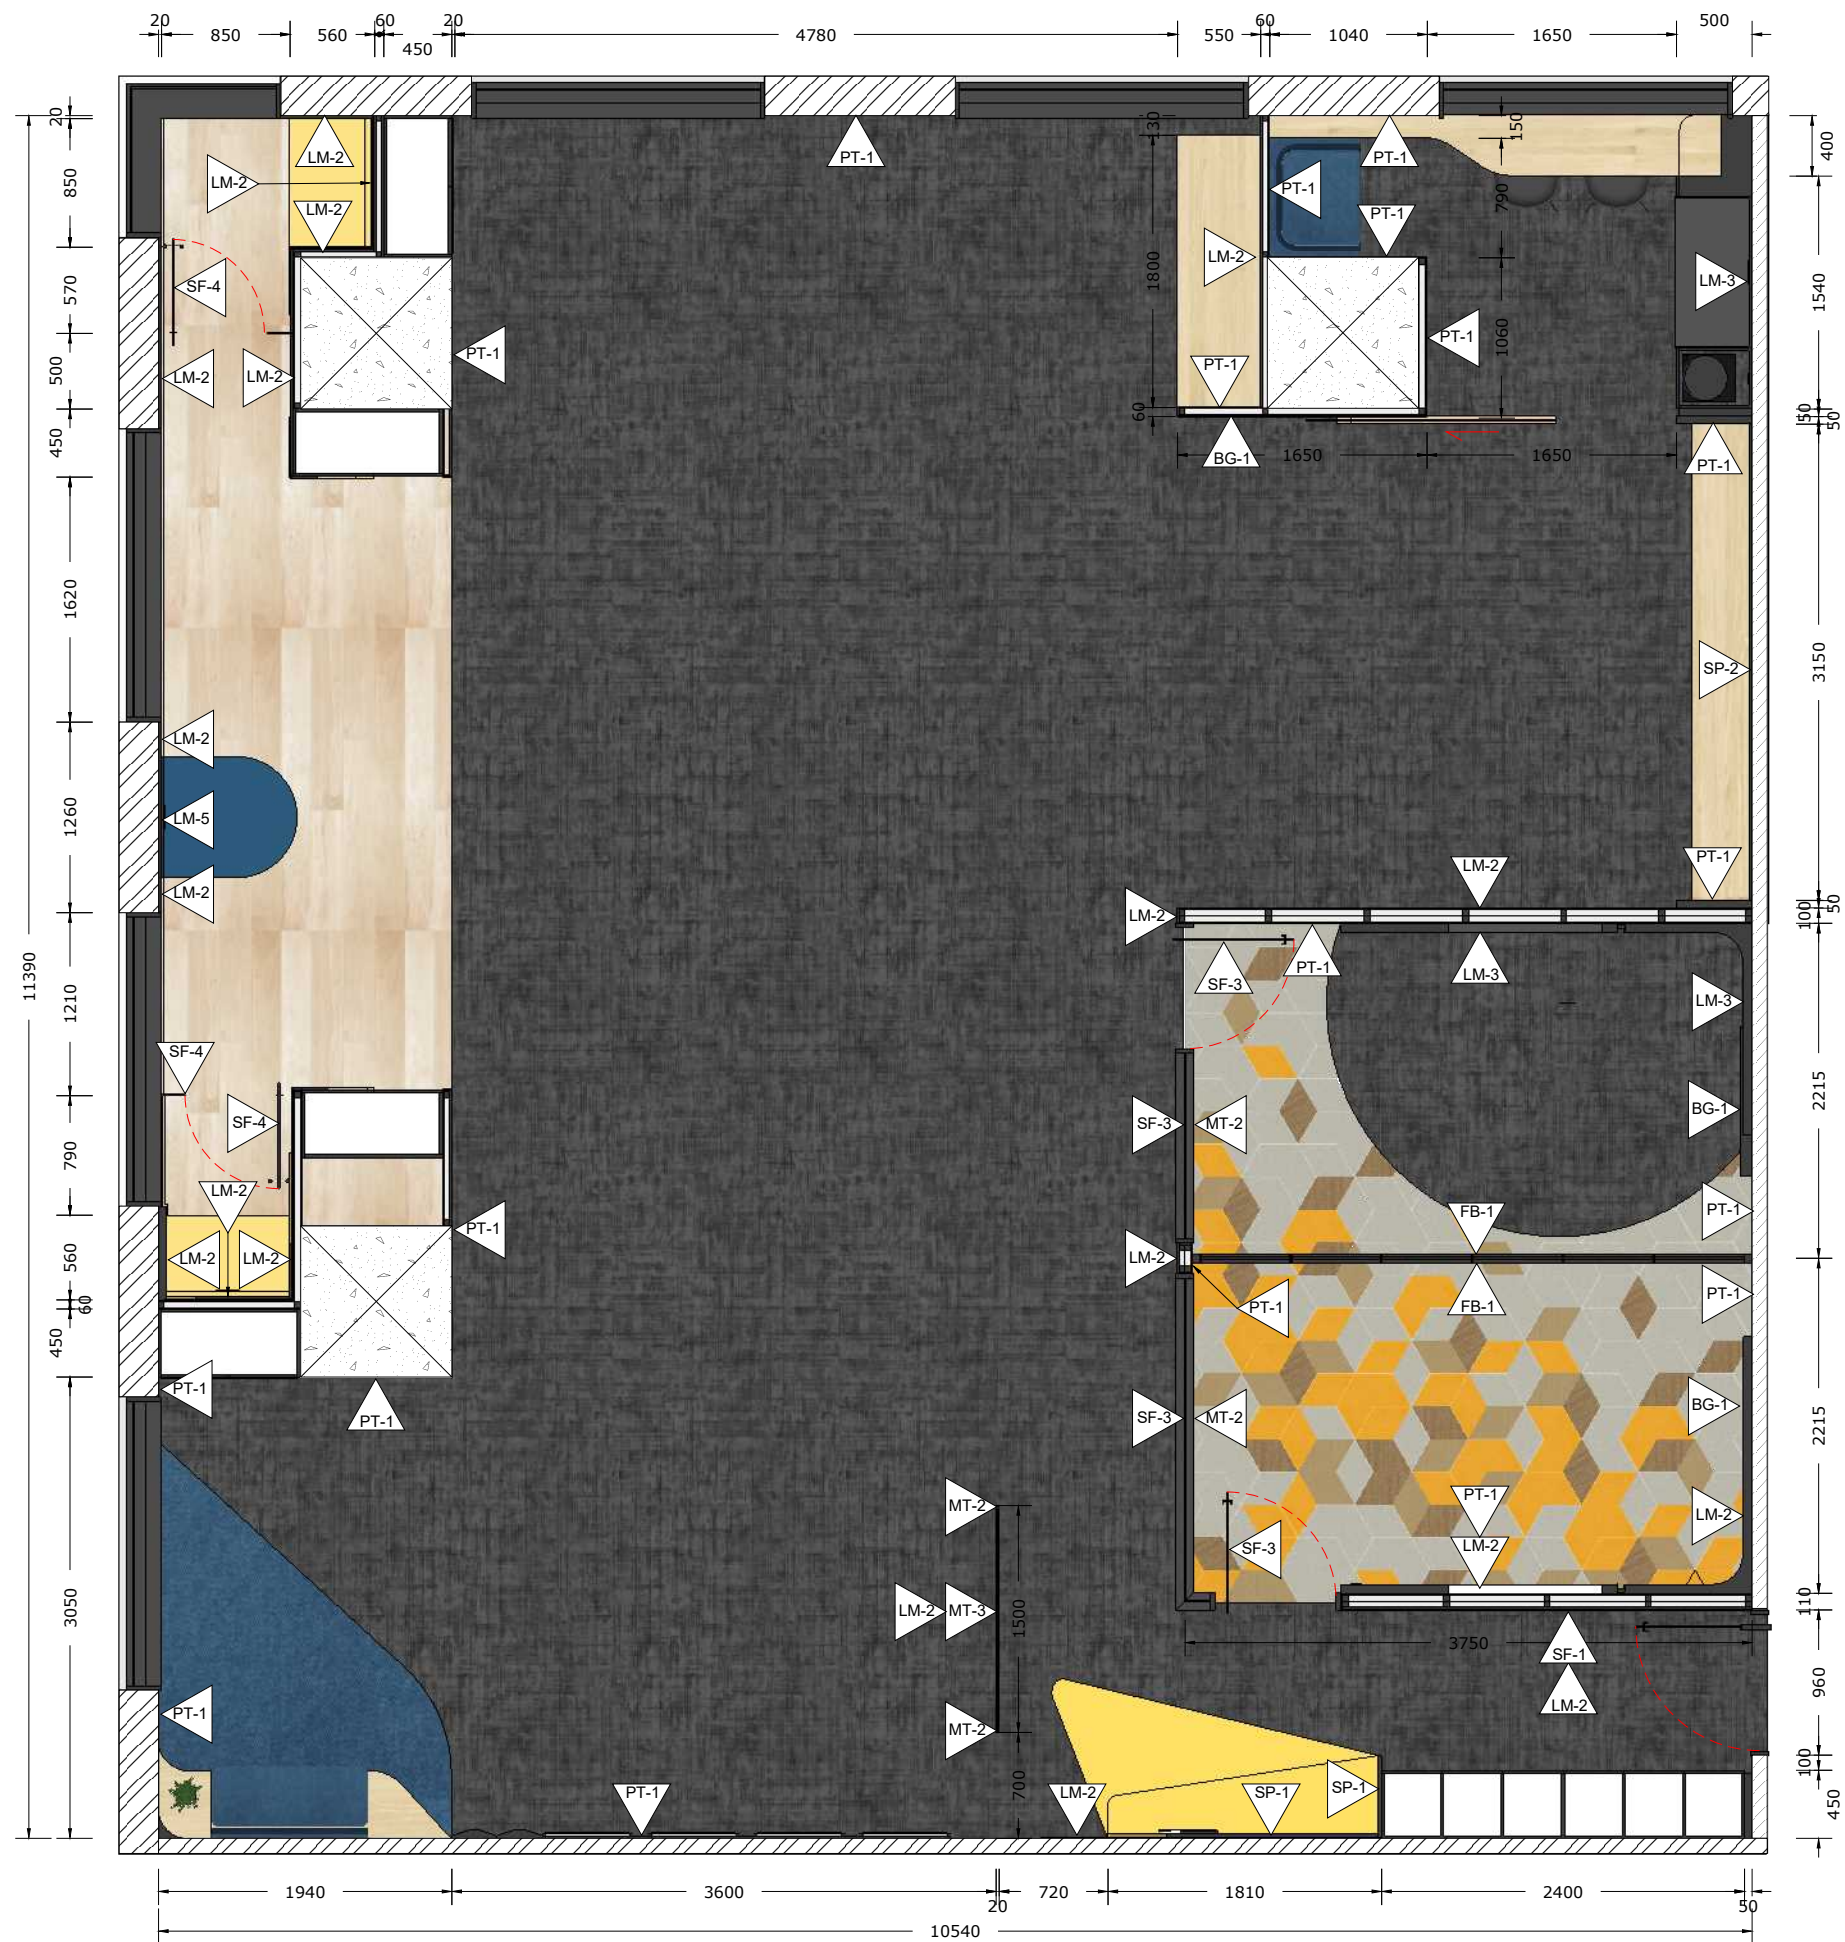


01 WALL FINISH PLAN
INT-104 Scale: 1:50

- NOTE :
- SPC-1 : SPC FLOOR, PATINA, LEMON
SPC-2 : PATINA, SKIRTING 80
- CP-1 : SMJ CARPET, BLUESTONE, TIMELESS GREY 50 X 50 CM
CP-2 : SMJ CARPET, CONCEPT LOOP, BLUE SCREEN 50 X 50 CM
CP-3 : SMJ CARPET, COLOR BOX, YELLOW LEMON 50 X 50 CM
CP-4 : VOXFLO, PRISM 01, HEXAGONS 50x43,3 CM
CP-5 : VOXFLO, PRISM 33, HEXAGONS 50x43,3 CM
CP-6 : VOXFLO, CRYSTAL 04 HEXAGONS 50x43,3 CM
CP-7 : VOXFLO, CRYSTAL 10 HEXAGONS 50x43,3 CM
- MT-1 : STAINLESS STEEL HAIRLINE H 80 MM
MT-2 : POWDER COATING METAL, BLACK, DOFF
MT-3 : POWDER COATING METAL, WHITE, DOFF
- PT-1 : PAINT, DULUX XXX
- SP-1 : SPRAY PAINT (DUCO) YELLOW
SP-2 : SPRAY PAINT (DUCO) BLUE
SP-3 : SPRAY PAINT (DUCO) TOSCA
- FB-1 : FABRIC, ATEJA LORENZIA, FESTUS 160
FB-2 : FABRIC, ATEJA LORENZIA, COLOR MATCH TO LM-4
FB-3 : FABRIC, VANIA, FORTE
- GL-1 : CLEAR GLASS
- BG-1 : BACKPAINTED GLASS, HIMALAYA ABADI - GLASSTONE - SUPER WHITE
- LM-1 : HPL, AICA AS-14062CS83 LIGHTGRAY LEGER STONE
LM-2 : HPL, CARTA CT 7878 T ARGENTINA CHERRY
LM-3 : HPL, TACO TH 006 AA MIDNIGHT GREY
LM-4 : HPL, TACO TH 021 AA CANARY YELLOW
- SF-1 : STICKER PRINTING, DOFF
SF-2 : ACRYLIC LASER CU FIN. IN SPRAY PAINT, DOFF
SF-3 : GRADATION STICKER ONE SIDE - WHITE
SF-4 : STICKER FILM GREY 40%

Bintaro Business Centre Building
Jl. RC Veteran No. 1-1 Bintaro
Phone: +62 21 7357679
Fax: +62 21 7433946
www.dezanstudio.com
admin@dezanstudio.com

CLIENT	
UNDP	
PROJECT	
2019 - UNDP PROJECT 3A	
DRAWING TITLE	
WALL FINISH PLAN	
DRAWING No.	REVISION
INT-104	REV A
SCALE 1:50 @A3	CHECKED AS
DATE November 5, 2020	DRAWN AS

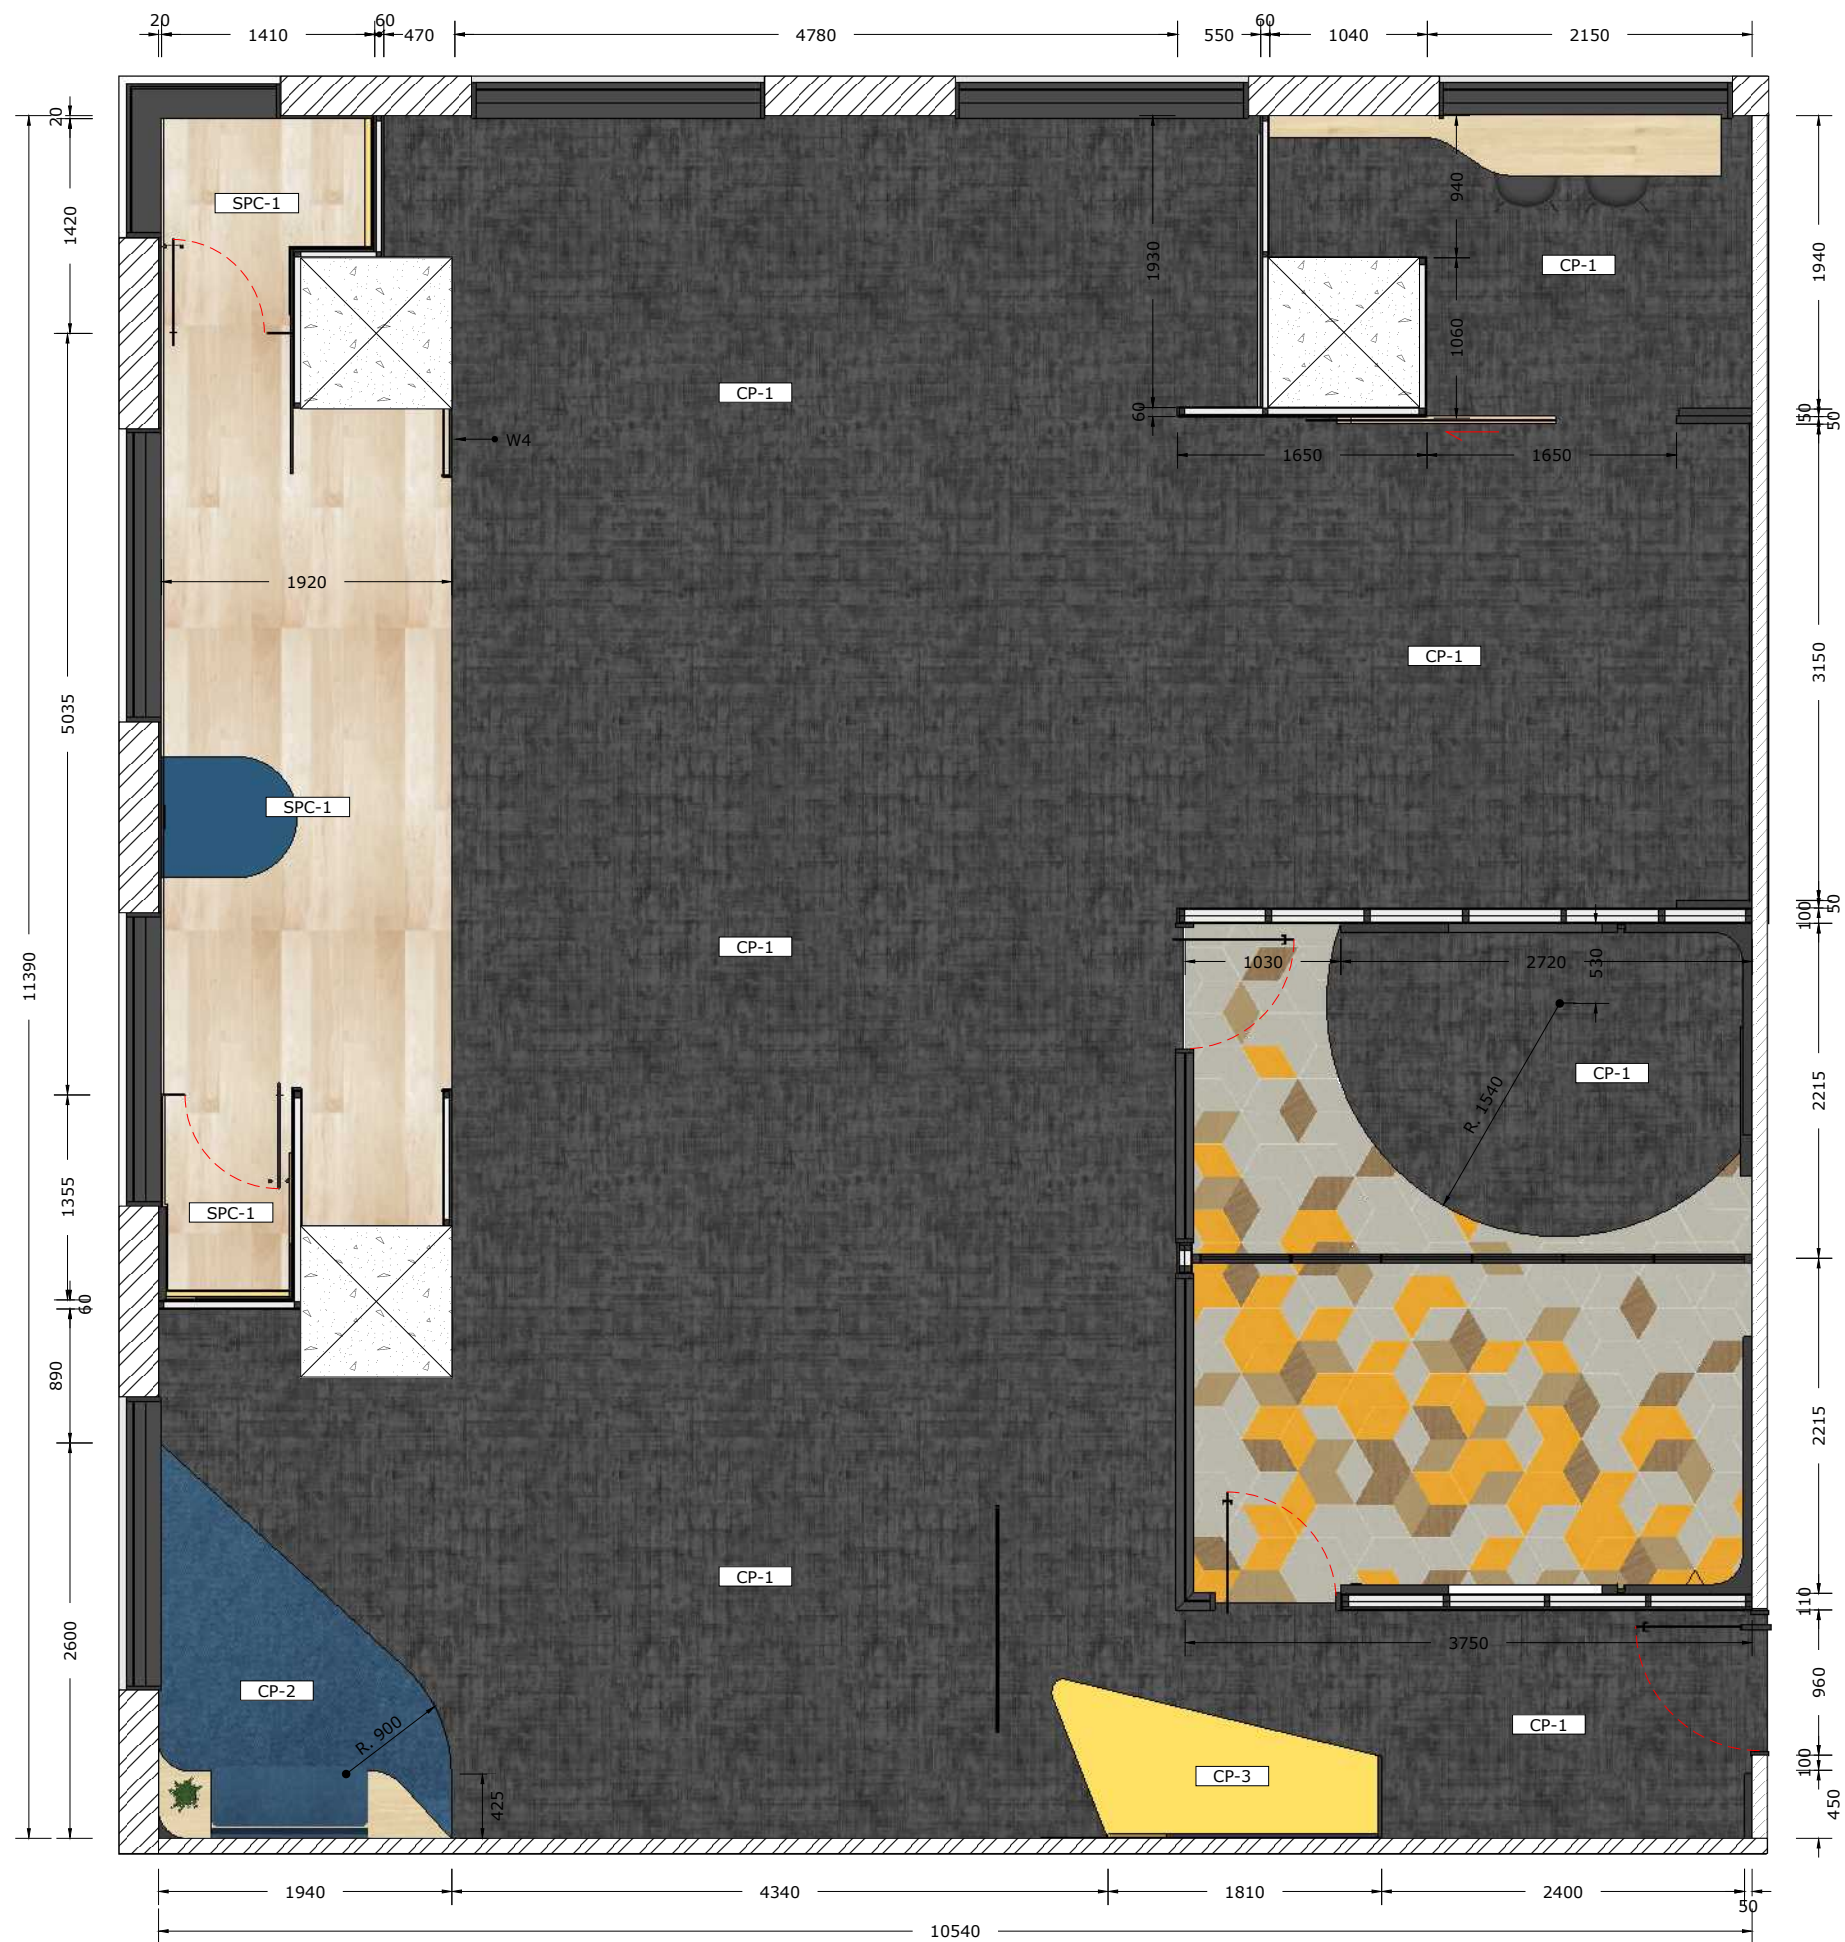


01 FLOOR FINISH PLAN
INT-105 Scale: 1:50

- NOTE :
- SPC-1 : SPC FLOOR, PATINA, LEMON
SPC-2 : PATINA, SKIRTING 80
- CP-1 : SMJ CARPET, BLUESTONE, TIMELESS GREY 50 X 50 CM
CP-2 : SMJ CARPET, CONCEPT LOOP, BLUE SCREEN 50 X 50 CM
CP-3 : SMJ CARPET, COLOR BOX, YELLOW LEMON 50 X 50 CM
CP-4 : VOXFLO, PRISM 01, HEXAGONS 50x43,3 CM
CP-5 : VOXFLO, PRISM 33, HEXAGONS 50x43,3 CM
CP-6 : VOXFLO, CRYSTAL 04 HEXAGONS 50x43,3 CM
CP-7 : VOXFLO, CRYSTAL 10 HEXAGONS 50x43,3 CM
- MT-1 : STAINLESS STEEL HAIRLINE H 80 MM
MT-2 : POWDER COATING METAL, BLACK, DOFF
MT-3 : POWDER COATING METAL, WHITE, DOFF
- PT-1 : PAINT, DULUX XXX
- SP-1 : SPRAY PAINT (DUCO) YELLOW
SP-2 : SPRAY PAINT (DUCO) BLUE
SP-3 : SPRAY PAINT (DUCO) TOSCA
- FB-1 : FABRIC, ATEJA LORENZIA, FESTUS 160
FB-2 : FABRIC, ATEJA LORENZIA, COLOR MATCH TO LM-4
FB-3 : FABRIC, VANIA, FORTE
- GL-1 : CLEAR GLASS
- BG-1 : BACKPAINTED GLASS, HIMALAYA ABADI - GLASSTONE - SUPER WHITE
- LM-1 : HPL, AICA AS-14062CS83 LIGHTGRAY LEGER STONE
LM-2 : HPL, CARTA CT 7878 T ARGENTINA CHERRY
LM-3 : HPL, TACO TH 006 AA MIDNIGHT GREY
LM-4 : HPL, TACO TH 021 AA CANARY YELLOW
- SF-1 : STICKER PRINTING, DOFF
SF-2 : ACRYLIC LASER CU FIN. IN SPRAY PAINT, DOFF
SF-3 : GRADATION STICKER ONE SIDE - WHITE
SF-4 : STICKER FILM GREY 40%

Bintaro Business Centre Building
Jl. RC Veteran No. 1-1 Bintaro
Phone: +62 21 7357679
Fax: +62 21 7433946
www.dezanstudio.com
admin@dezanstudio.com

CLIENT	
UNDP	
PROJECT	
2019 - UNDP PROJECT 3A	
DRAWING TITLE	
FLOOR FINISH PLAN	
DRAWING No.	REVISION
INT-105	REV A
SCALE	1:50 @A3
DATE	November 5, 2020
CHECKED	AS
DRAWN	AS

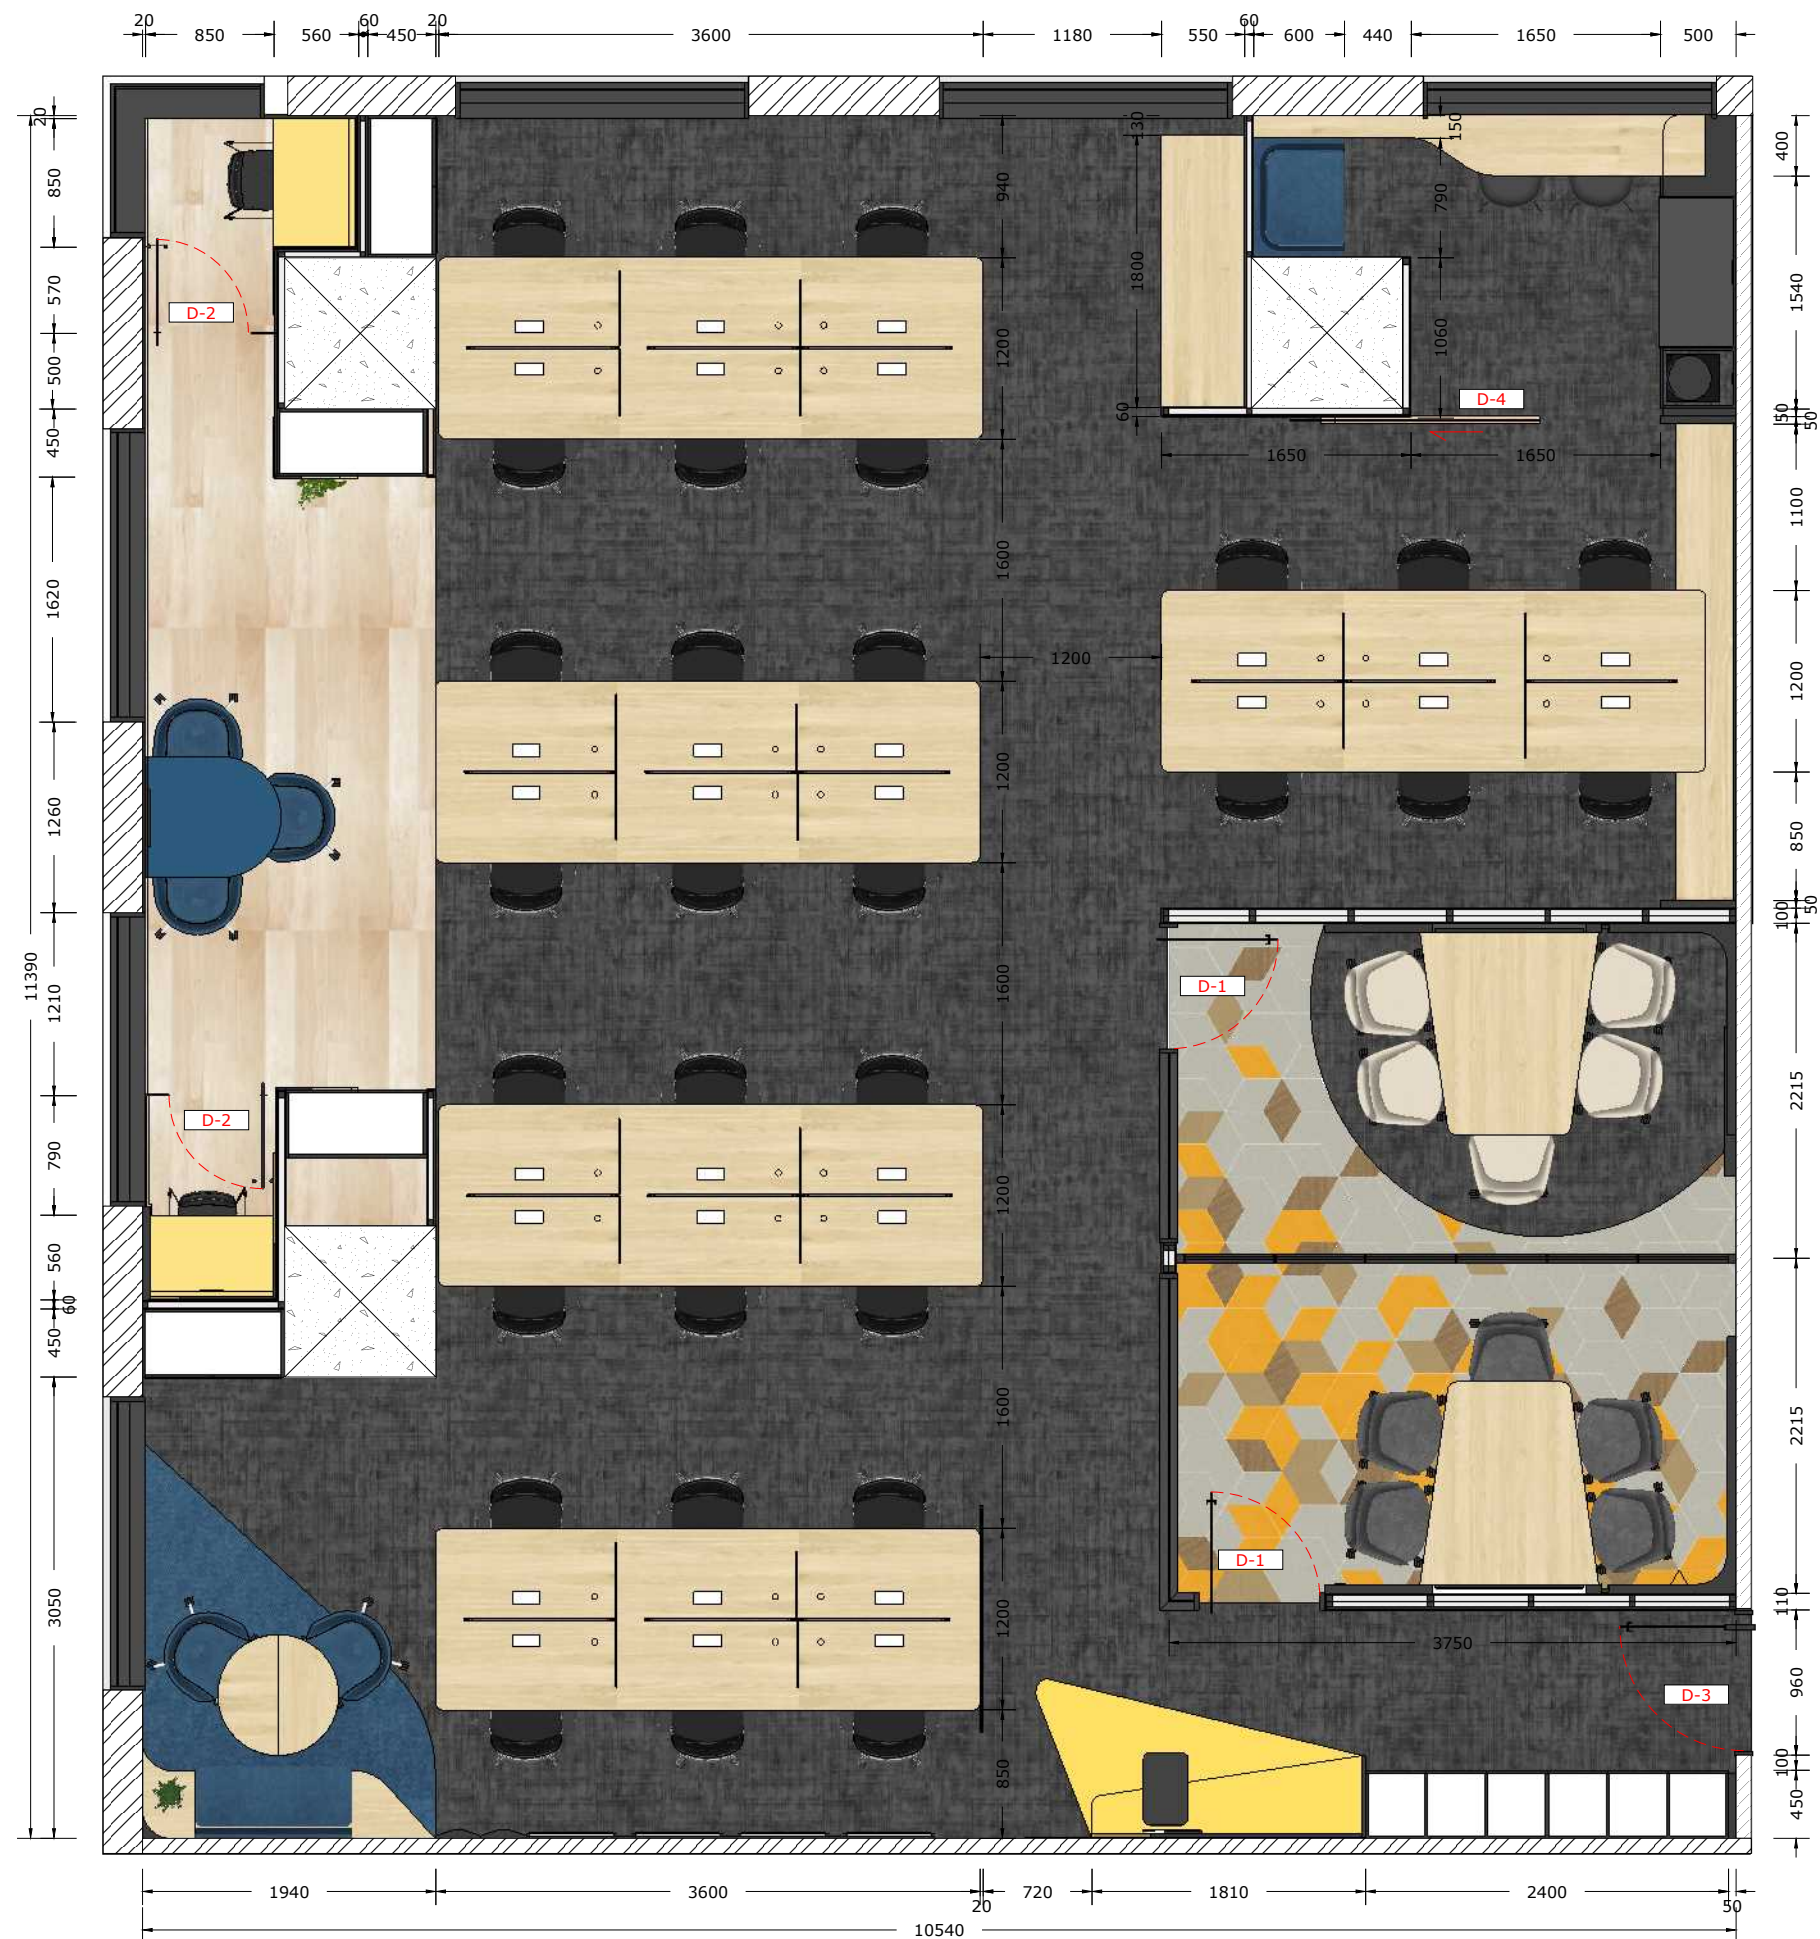

01 DOOR PLAN
INT-106 Scale: 1:50

NOTE :

DEZAN
STUDIO

Bintaro Business Centre Building
Jl. RC Veteran No. 1-1 Bintaro
Phone: +62 21 7357679
Fax: +62 21 7433946
www.dezanstudio.com
admin@dezanstudio.com

CLIENT

UNDP

PROJECT

2019 - UNDP PROJECT 3A

DRAWING TITLE

DOOR PLAN

DRAWING No.

INT-106

SCALE 1:50 @A3

DATE November 5, 2020

REVISION

REV A

CHECKED AS

DRAWN AS



NOTE :

- SINGLE SWITCH
PANASONIC WESJ78029 + WESJ5941
STYLE E MATTE BLACK
- DOUBLE SWITCH
PANASONIC WESJ78029 + WESJ5931
STYLE E MATTE BLACK
- SINGLE POWER OUTLET
PANASONIC WESJP1121B
STYLE E MATTE BLACK
- DOUBLE POWER OUTLET
PANASONIC WESJP1122B
STYLE E MATTE BLACK
- SINGLE POWER OUTLET + DOUBLE SWITCH
PANASONIC WESJP11212+ DOUBLE WEJP5931B
STYLE E MATTE BLACK
- DOUBLE POWER OUTLET +HDMI + USB OUTLET
PANASONIC WESJP11223 + WEG2021B + PORT
USB BLACK
- SINGLE DATA OUTLET
PANASONIC WESJ78019B + WES24886H
STYLE E MATTE BLACK
- DOUBLE DATA OUTLET
PANASONIC WESJ78029B + DOUBLE
WES24886H
STYLE E MATTE BLACK
- POWER BOX
2 POWER OUTLET STANDARD + USB OUTLET





Bintaro Business Centre Building
Jl. RC Veteran No. 1-1 Bintaro
Phone: +62 21 7357679
Fax: +62 21 7433946
www.dezanstudio.com
admin@dezanstudio.com

CLIENT

UNDP


PROJECT

2019 - UNDP PROJECT 3A

DRAWING TITLE

ELECTRICAL PLAN

DRAWING No.	REVISION
INT-107	REV A
SCALE 1:50 @A3	CHECKED AS
DATE November 5, 2020	DRAWN AS

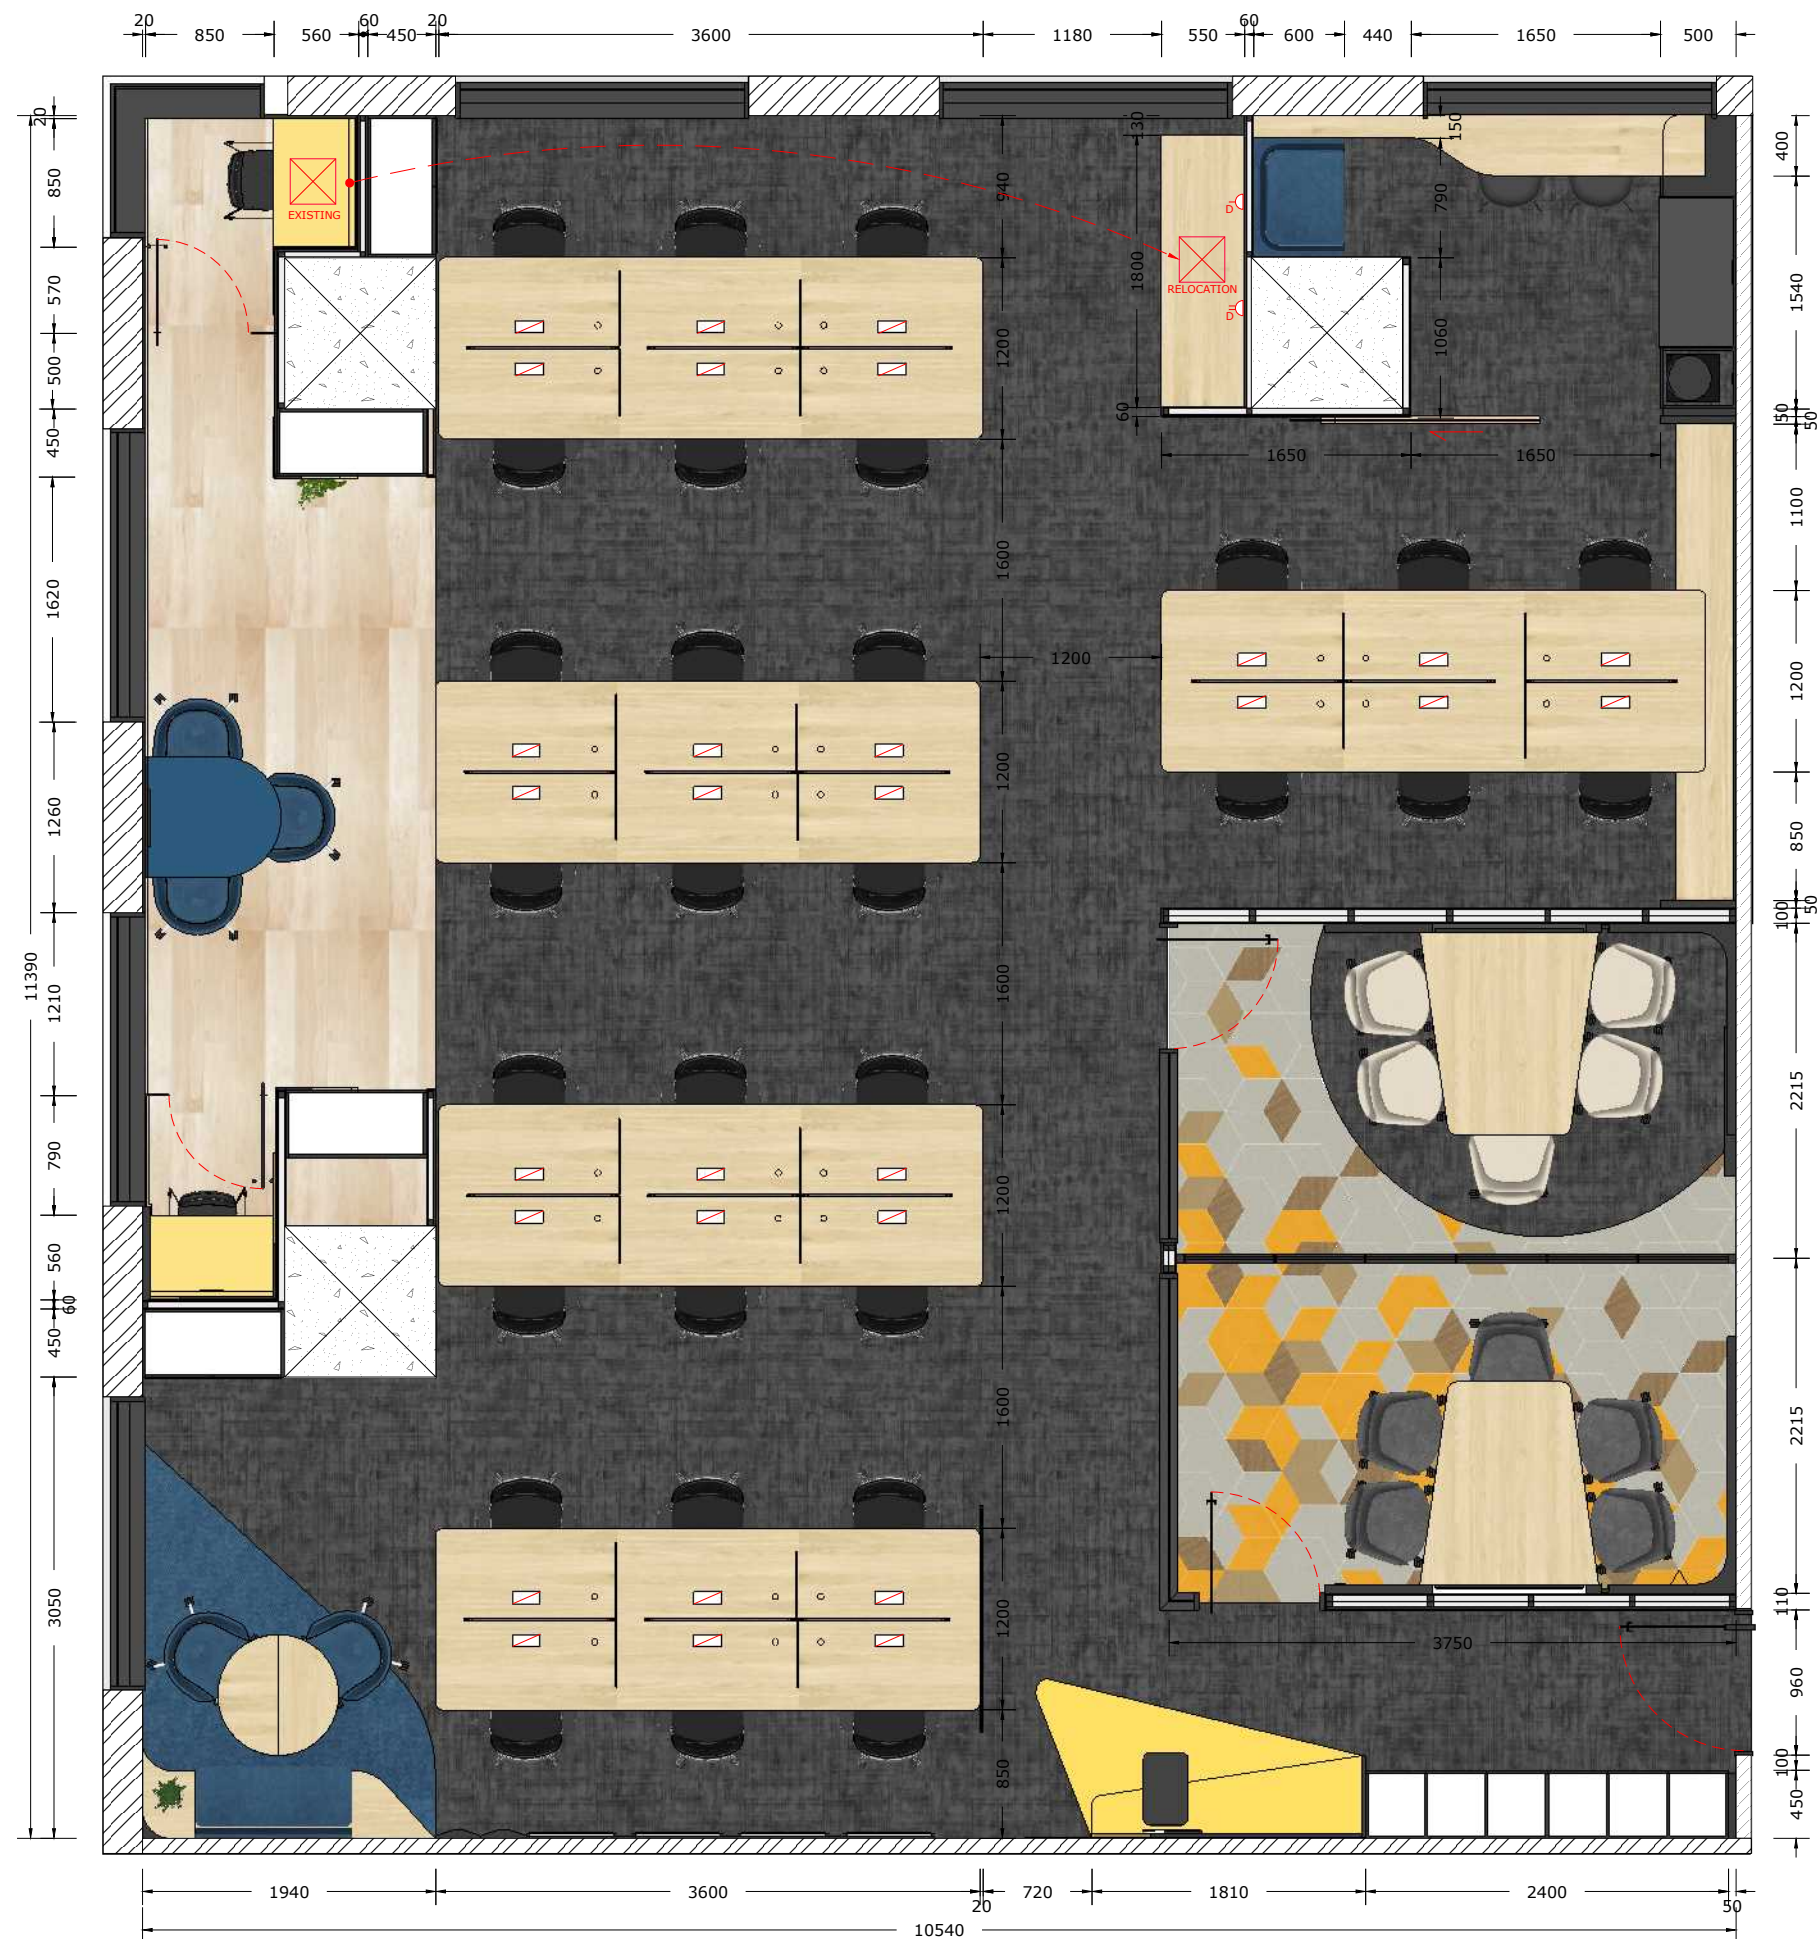

01 HUB & DATA PLAN
INT-108 Scale: 1:50

- NOTE :
- HUB LAN SWITCHER
 - SINGLE DATA OUTLET PANASONIC WESJ78019B + WES24886H STYLE E MATTE BLACK
 - DOUBLE DATA OUTLET PANASONIC WESJ78029B + DOUBLE WES24886H STYLE E MATTE BLACK
 - POWER BOX 2 POWER OUTLET STANDARD + USB OUTLET



Bintaro Business Centre Building
Jl. RC Veteran No. 1-1 Bintaro
Phone: +62 21 7357679
Fax: +62 21 7433946
www.dezanstudio.com
admin@dezanstudio.com

CLIENT

UNDP

PROJECT

2019 - UNDP PROJECT 3A

DRAWING TITLE

HUB & DATA PLAN

DRAWING No.

INT-108

REVISION

REV A

SCALE 1:50 @A3

DATE November 5, 2020

CHECKED AS

DRAWN AS



01 REFLECTED CEILING PLAN
INT-109 Scale: 1:50

NOTE :
CL-1 : EXISTING ACOUSTIC CEILING
CL-2 : GYPSUM 9 MM THK INCLUDE HOLLOW FRAME 40 X 40 X 0.4 MM
PT-1 : PAINT, DULUX


DEZAN STUDIO
Bintaro Business Centre Building
Jl. RC Veteran No. 1-1 Bintaro
Phone: +62 21 7357679
Fax: +62 21 7433946
www.dezanstudio.com
admin@dezanstudio.com

CLIENT			
UNDP			
PROJECT			
2019 - UNDP PROJECT 3A			
DRAWING TITLE			
REFLECTED CEILING PLAN			
DRAWING No.	REVISION		
INT-109	REV A		
SCALE	1:50 @A3	CHECKED	AS
DATE	November 5, 2020	DRAWN	AS



01 LIGHTING PLAN
INT-110 Scale: 1:50

 NOTE :



LT LAMP (USE EXISTING)



DOWNLIGHT EXISTING



NEW DOWNLIGHT FLAT



SPOTLIGHT



INDIRECT LIGHTING
LED STRIP LAMP
COLOR : WARM WHITE



HANGING LAMP 1
INFORMA - EGLARE HANGING
LAMP
COLOR : DARK GREY
DIM : D 180 MM



HANGING LAMP 2
INFORMA - EGLARE THIN HAT
E27
COLOR : BLACK
DIM : D 190 X 190 MM



WALL LAMP 1
INFORMA - EGLARE RETRO
WALL LAMP
COLOR : WHITE
DIM : 255 x 155 x 230 MM



Bintaro Business Centre Building
Jl. RC Veteran No. 1-1 Bintaro
Phone: +62 21 7357679
Fax: +62 21 7433946
www.dezanstudio.com
admin@dezanstudio.com

CLIENT

UNDP

PROJECT

2019 - UNDP PROJECT 3A

DRAWING TITLE

LIGHTING PLAN

DRAWING No.	REVISION	
INT-110	REV A	
SCALE	1:50 @A3	CHECKED AS
DATE	November 5, 2020	DRAWN AS



01 AC GRILL PLAN
INT-111 Scale: 1:50

- NOTE :
- SG : SUPPLY GRILL
 - RG : RETURN GRILL
 - DF : DOWN FLOW
 - SF : SIDE FLOW
-  AC DIFFUSER EXISTING

DEZAN STUDIO
Bintaro Business Centre Building
Jl. RC Veteran No. 1-1 Bintaro
Phone: +62 21 7357679
Fax: +62 21 7433946
www.dezanstudio.com
admin@dezanstudio.com

CLIENT

UNDP

PROJECT

2019 - UNDP PROJECT 3A

DRAWING TITLE

AC GRILL PLAN

DRAWING No.	REVISION	
INT-111	REV A	
SCALE	1:50 @A3	CHECKED AS
DATE	November 5, 2020	DRAWN AS



01
INT-112
SPEAKER, SPRINKLER & SMOKE DETECTOR PLAN
Scale: 1:50

DEZAN
STUDIO

Bintaro Business Centre Building
Jl. RC Veteran No. 1-1 Bintaro
Phone: +62 21 7357679
Fax: +62 21 7433946
www.dezanstudio.com
admin@dezanstudio.com

CLIENT

UNDP


PROJECT

2019 - UNDP PROJECT 3A

DRAWING TITLE

SPEAKER, SPRINKLER &
SMOKE DETECTOR PLAN


DRAWING No.	REVISION
INT-112	REV A
SCALE 1:50 @A3	CHECKED AS
DATE November 5, 2020	DRAWN AS

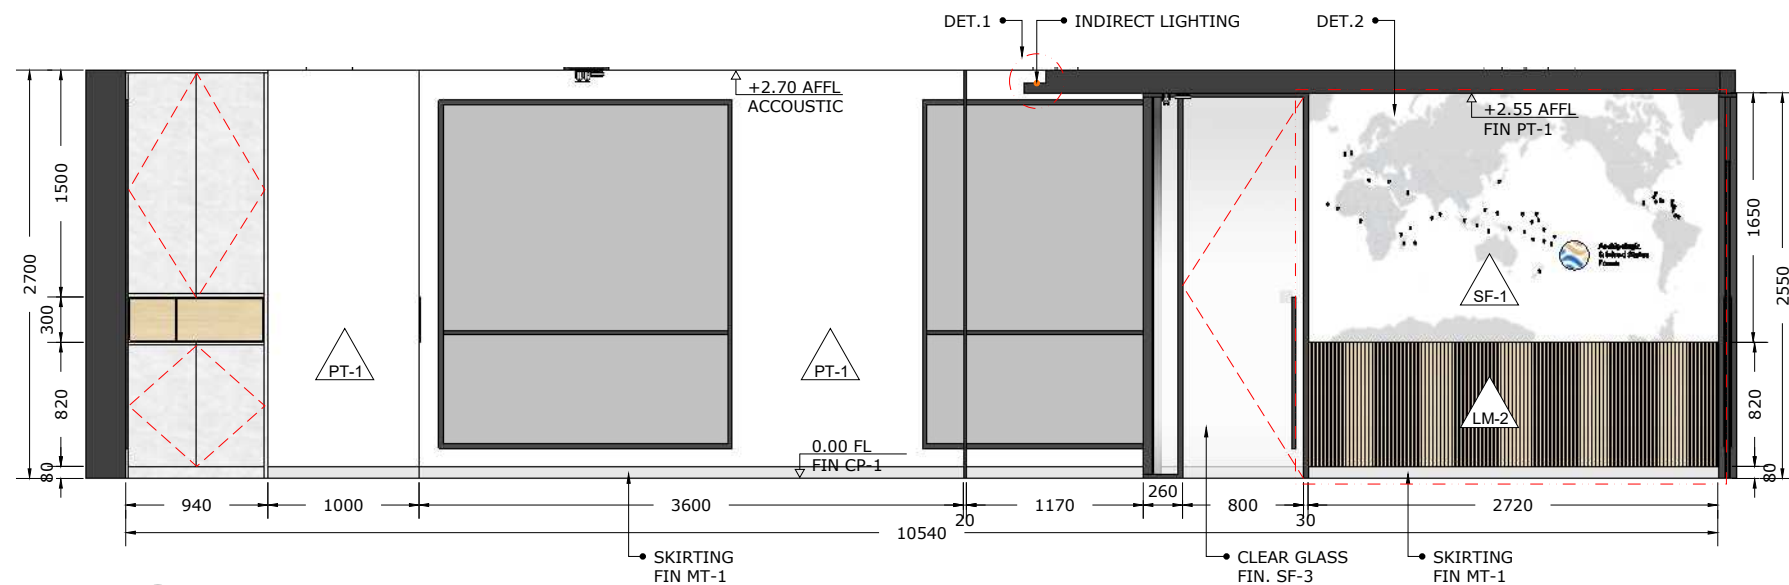


02 SECTION A
INT-113 Scale: 1:50



01 KEYPLAN
INT-113 Scale: 1:200

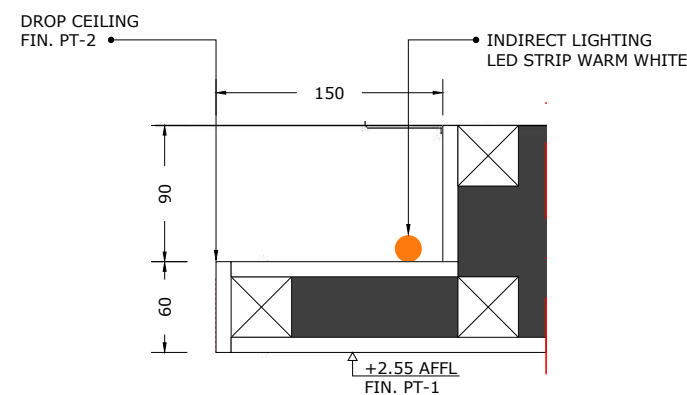

03 DETAIL 1
INT-113 Scale: 1:5

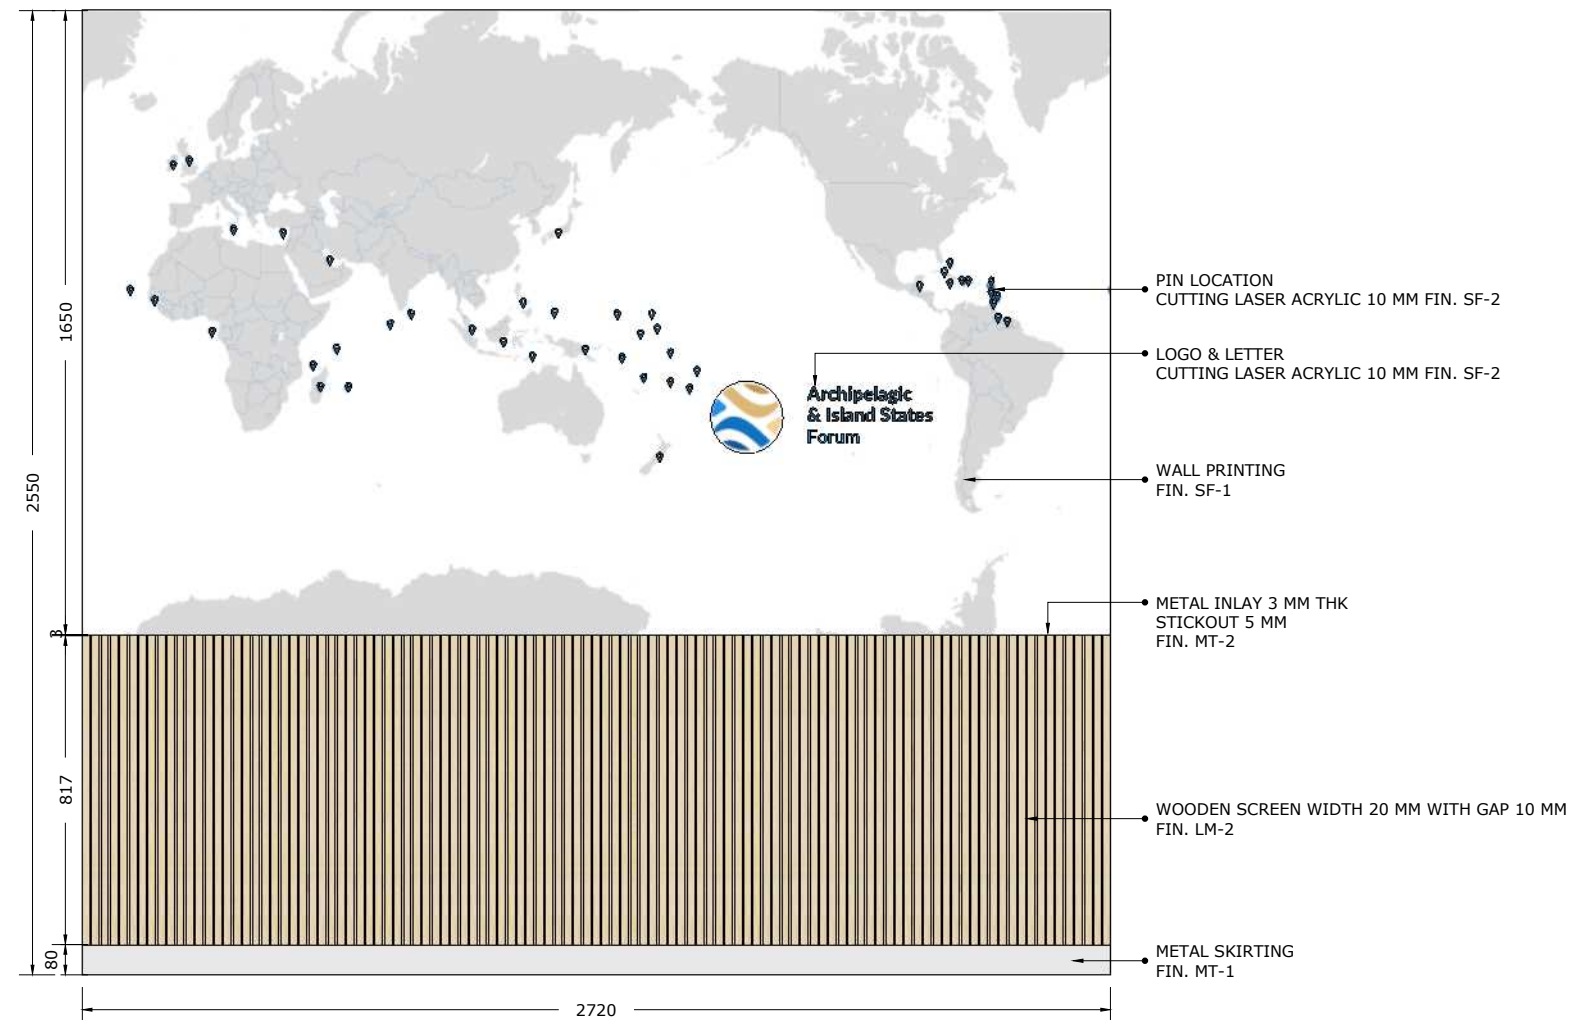

04 DETAIL 2
INT-113 Scale: 1:20

- NOTE :
- SPC-1 : SPC FLOOR, PATINA, LEMON
SPC-2 : PATINA, SKIRTING 80
- CP-1 : SMJ CARPET, BLUESTONE, TIMELESS GREY 50 X 50 CM
CP-2 : SMJ CARPET, CONCEPT LOOP, BLUE SCREEN 50 X 50 CM
CP-3 : SMJ CARPET, COLOR BOX, YELLOW LEMON 50 X 50 CM
CP-4 : VOXFLO, PRISM 01, HEXAGONS 50x43,3 CM
CP-5 : VOXFLO, PRISM 33, HEXAGONS 50x43,3 CM
CP-6 : VOXFLO, CRYSTAL 04 HEXAGONS 50x43,3 CM
CP-7 : VOXFLO, CRYSTAL 10 HEXAGONS 50x43,3 CM
- MT-1 : STAINLESS STEEL HAIRLINE H 80 MM
MT-2 : POWDER COATING METAL, BLACK, DOFF
MT-3 : POWDER COATING METAL, WHITE, DOFF
- PT-1 : PAINT, DULUX XXX
- SP-1 : SPRAY PAINT (DUCO) YELLOW
SP-2 : SPRAY PAINT (DUCO) BLUE
SP-3 : SPRAY PAINT (DUCO) TOSCA
- FB-1 : FABRIC, ATEJA LORENZIA, FESTUS 160
FB-2 : FABRIC, ATEJA LORENZIA, COLOR MATCH TO LM-4
FB-3 : FABRIC, VANIA, FORTE
- GL-1 : CLEAR GLASS
- BG-1 : BACKPAINTED GLASS, HIMALAYA ABADI - GLASSTONE - SUPER WHITE
- LM-1 : HPL, AICA AS-14062CS83 LIGHTGRAY LEGER STONE
LM-2 : HPL, CARTA CT 7878 T ARGENTINA CHERRY
LM-3 : HPL, TACO TH 006 AA MIDNIGHT GREY
LM-4 : HPL, TACO TH 021 AA CANARY YELLOW
- SF-1 : STICKER PRINTING, DOFF
SF-2 : ACRYLIC LASER CU FIN. IN SPRAY PAINT, DOFF
SF-3 : GRADATION STICKER ONE SIDE - WHITE
SF-4 : STICKER FILM GREY 40%

Bintaro Business Centre Building
Jl. RC Veteran No. 1-1 Bintaro
Phone: +62 21 7357679
Fax: +62 21 7433946
www.dezanstudio.com
admin@dezanstudio.com

CLIENT

UNDP


PROJECT

2019 - UNDP PROJECT 3A


DRAWING TITLE

SECTION A

DRAWING No.	REVISION
INT-113	REV A
SCALE AS SHOWN@A3	CHECKED AS
DATE November 5, 2020	DRAWN AS

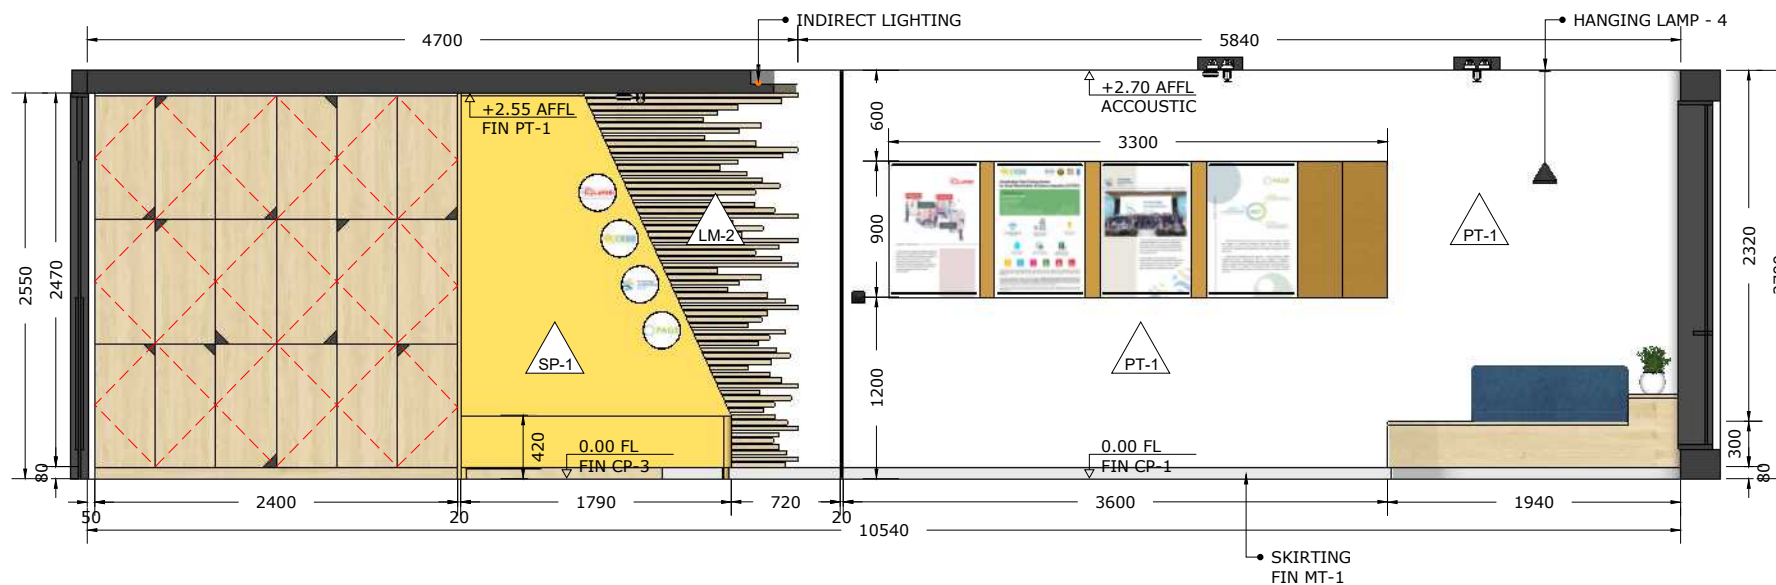

02 SECTION B
INT-114 Scale: 1:50

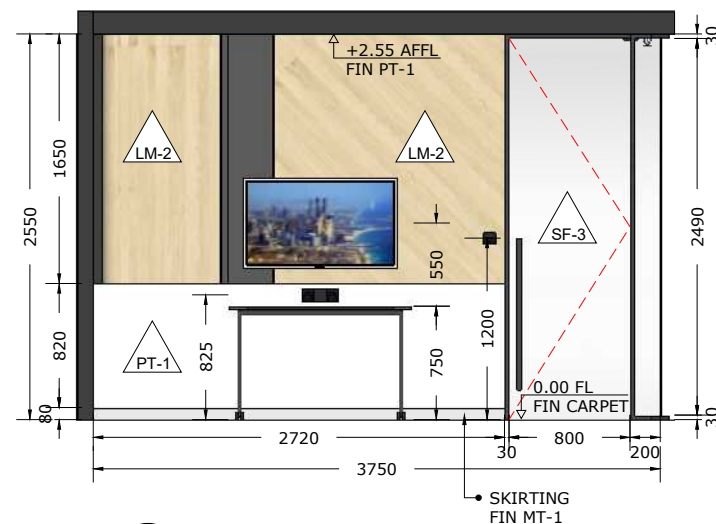

03 SECTION C
INT-114 Scale: 1:50



01 KEYPLAN
INT-114 Scale: 1:200

- NOTE :
- SPC-1 : SPC FLOOR, PATINA, LEMON
SPC-2 : PATINA, SKIRTING 80
- CP-1 : SMJ CARPET, BLUESTONE, TIMELESS GREY 50 X 50 CM
CP-2 : SMJ CARPET, CONCEPT LOOP, BLUE SCREEN 50 X 50 CM
CP-3 : SMJ CARPET, COLOR BOX, YELLOW LEMON 50 X 50 CM
CP-4 : VOXFLO, PRISM 01, HEXAGONS 50x43,3 CM
CP-5 : VOXFLO, PRISM 33, HEXAGONS 50x43,3 CM
CP-6 : VOXFLO, CRYSTAL 04 HEXAGONS 50x43,3 CM
CP-7 : VOXFLO, CRYSTAL 10 HEXAGONS 50x43,3 CM
- MT-1 : STAINLESS STEEL HAIRLINE H 80 MM
MT-2 : POWDER COATING METAL, BLACK, DOFF
MT-3 : POWDER COATING METAL, WHITE, DOFF
- PT-1 : PAINT, DULUX XXX
- SP-1 : SPRAY PAINT (DUCO) YELLOW
SP-2 : SPRAY PAINT (DUCO) BLUE
SP-3 : SPRAY PAINT (DUCO) TOSCA
- FB-1 : FABRIC, ATEJA LORENZIA, FESTUS 160
FB-2 : FABRIC, ATEJA LORENZIA, COLOR MATCH TO LM-4
FB-3 : FABRIC, VANIA, FORTE
- GL-1 : CLEAR GLASS
- BG-1 : BACKPAINTED GLASS, HIMALAYA ABADI - GLASSTONE - SUPER WHITE
- LM-1 : HPL, AICA AS-14062CS83 LIGHTGRAY LEGER STONE
LM-2 : HPL, CARTA CT 7878 T ARGENTINA CHERRY
LM-3 : HPL, TACO TH 006 AA MIDNIGHT GREY
LM-4 : HPL, TACO TH 021 AA CANARY YELLOW
- SF-1 : STICKER PRINTING, DOFF
SF-2 : ACRYLIC LASER CU FIN. IN SPRAY PAINT, DOFF
SF-3 : GRADATION STICKER ONE SIDE - WHITE
SF-4 : STICKER FILM GREY 40%

Bintaro Business Centre Building
Jl. RC Veteran No. 1-1 Bintaro
Phone: +62 21 7357679
Fax: +62 21 7433946
www.dezanstudio.com
admin@dezanstudio.com

CLIENT

UNDP


PROJECT

2019 - UNDP PROJECT 3A


DRAWING TITLE

SECTION B & C


DRAWING No.	REVISION
INT-114	REV A
SCALE 1:50 @A3	CHECKED AS
DATE November 5, 2020	DRAWN AS

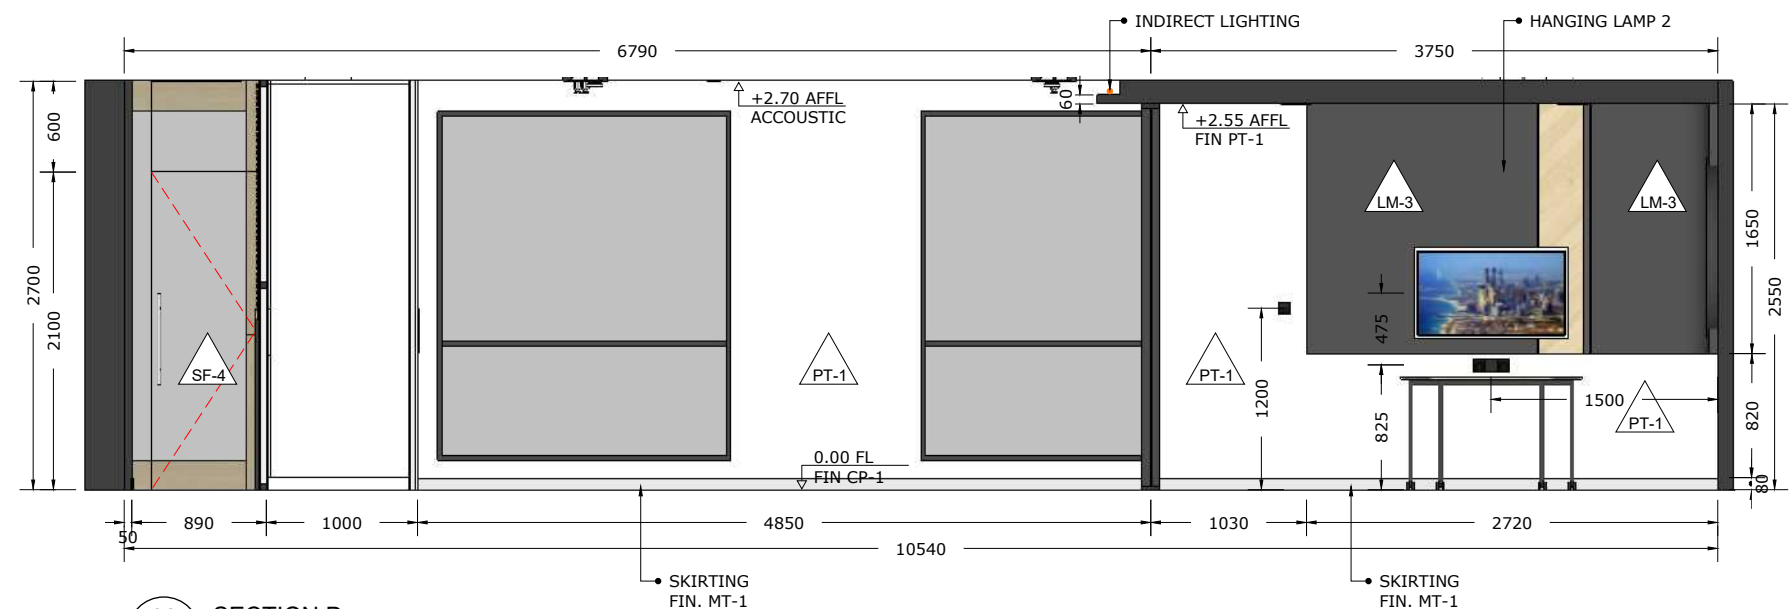

02 SECTION D
INT-115 Scale: 1:50

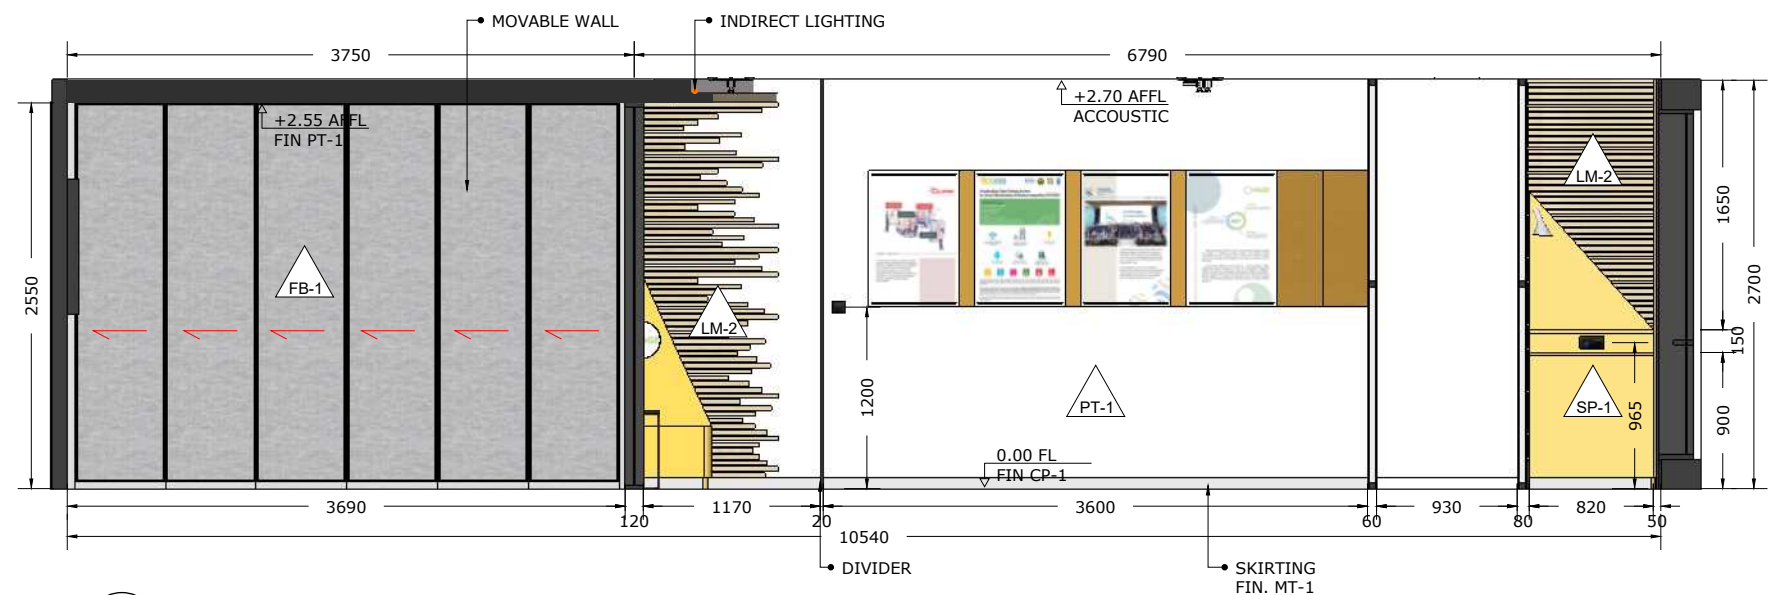

03 SECTION E
INT-115 Scale: 1:50

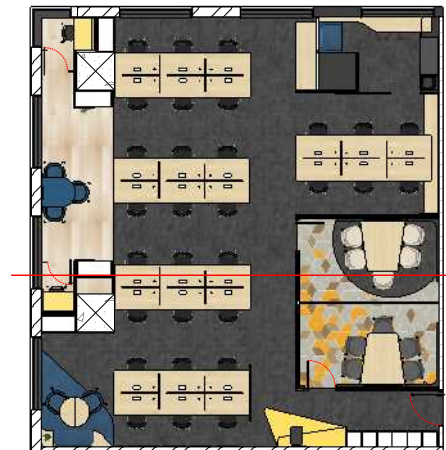

01 KEYPLAN
INT-115 Scale: 1:200

- NOTE :
- SPC-1 : SPC FLOOR, PATINA, LEMON
SPC-2 : PATINA, SKIRTING 80
- CP-1 : SMJ CARPET, BLUESTONE, TIMELESS GREY 50 X 50 CM
CP-2 : SMJ CARPET, CONCEPT LOOP, BLUE SCREEN 50 X 50 CM
CP-3 : SMJ CARPET, COLOR BOX, YELLOW LEMON 50 X 50 CM
CP-4 : VOXFLO, PRISM 01, HEXAGONS 50x43,3 CM
CP-5 : VOXFLO, PRISM 33, HEXAGONS 50x43,3 CM
CP-6 : VOXFLO, CRYSTAL 04 HEXAGONS 50x43,3 CM
CP-7 : VOXFLO, CRYSTAL 10 HEXAGONS 50x43,3 CM
- MT-1 : STAINLESS STEEL HAIRLINE H 80 MM
MT-2 : POWDER COATING METAL, BLACK, DOFF
MT-3 : POWDER COATING METAL, WHITE, DOFF
- PT-1 : PAINT, DULUX XXX
- SP-1 : SPRAY PAINT (DUCO) YELLOW
SP-2 : SPRAY PAINT (DUCO) BLUE
SP-3 : SPRAY PAINT (DUCO) TOSCA
- FB-1 : FABRIC, ATEJA LORENZIA, FESTUS 160
FB-2 : FABRIC, ATEJA LORENZIA, COLOR MATCH TO LM-4
FB-3 : FABRIC, VANIA, FORTE
- GL-1 : CLEAR GLASS
- BG-1 : BACKPAINTED GLASS, HIMALAYA ABADI - GLASSTONE - SUPER WHITE
- LM-1 : HPL, AICA AS-14062CS83 LIGHTGRAY LEGER STONE
LM-2 : HPL, CARTA CT 7878 T ARGENTINA CHERRY
LM-3 : HPL, TACO TH 006 AA MIDNIGHT GREY
LM-4 : HPL, TACO TH 021 AA CANARY YELLOW
- SF-1 : STICKER PRINTING, DOFF
SF-2 : ACRYLIC LASER CU FIN. IN SPRAY PAINT, DOFF
SF-3 : GRADATION STICKER ONE SIDE - WHITE
SF-4 : STICKER FILM GREY 40%

Bintaro Business Centre Building
Jl. RC Veteran No. 1-1 Bintaro
Phone: +62 21 7357679
Fax: +62 21 7433946
www.dezanstudio.com
admin@dezanstudio.com

CLIENT

UNDP


PROJECT

2019 - UNDP PROJECT 3A


DRAWING TITLE

SECTION D & E


DRAWING No.	REVISION
INT-115	REV A
SCALE 1:50 @A3	CHECKED AS
DATE November 5, 2020	DRAWN AS

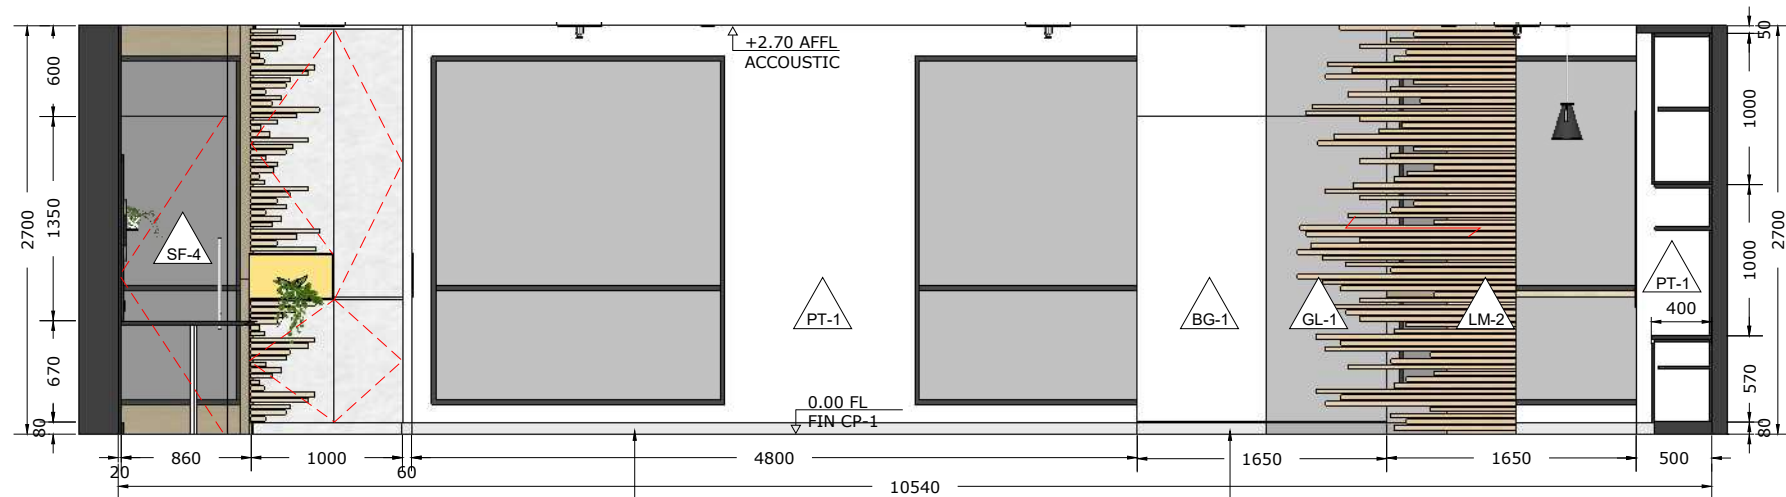

02 SECTION F
INT-116 Scale: 1:50

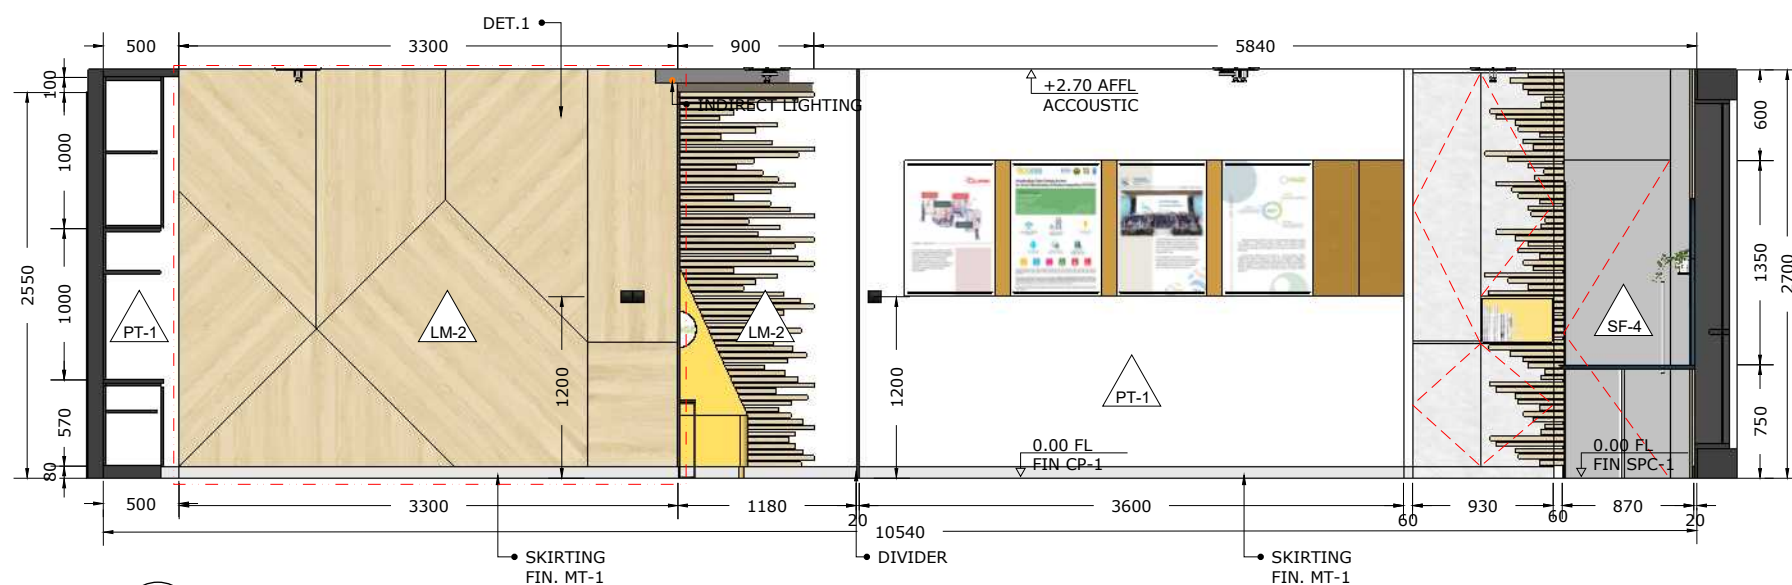

03 SECTION G
INT-116 Scale: 1:50

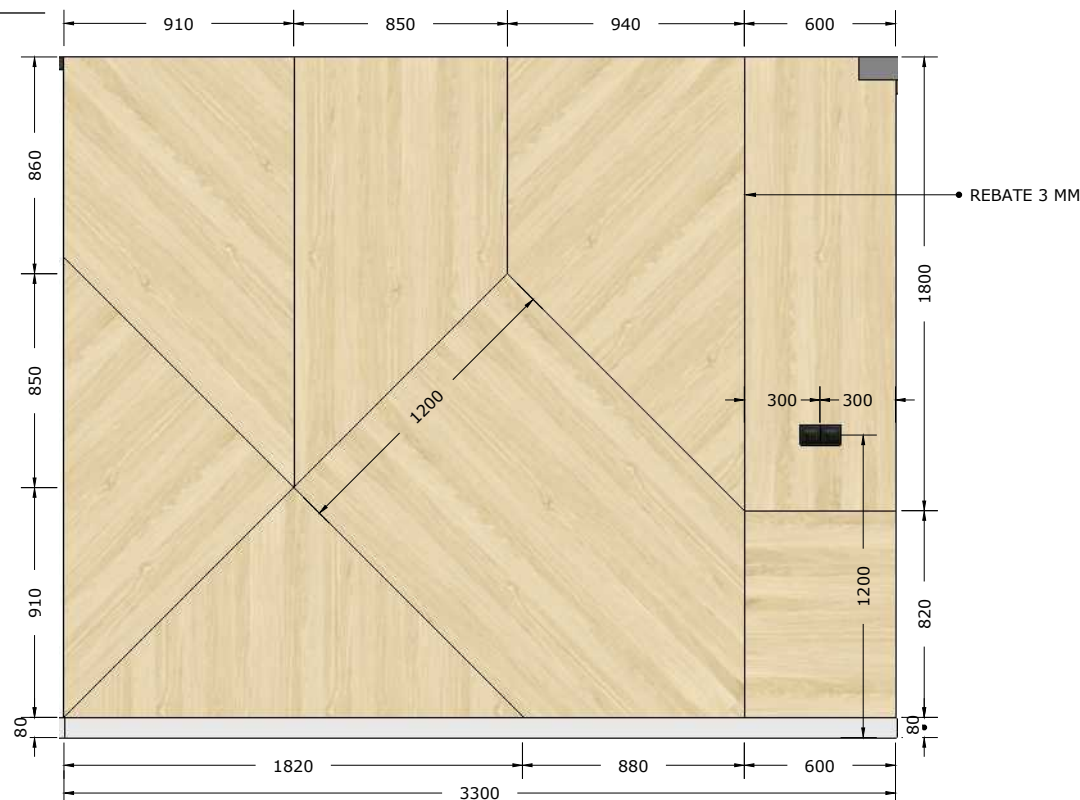

04 DETAIL 1
INT-116 Scale: 1:30



01 KEYPLAN
INT-116 Scale: 1:200

NOTE :

SPC-1 : SPC FLOOR, PATINA, LEMON
SPC-2 : PATINA, SKIRTING 80

CP-1 : SMJ CARPET, BLUESTONE, TIMELESS GREY
50 X 50 CM
CP-2 : SMJ CARPET, CONCEPT LOOP, BLUE SCREEN
50 X 50 CM
CP-3 : SMJ CARPET, COLOR BOX, YELLOW LEMON
50 X 50 CM
CP-4 : VOXFLO, PRISM 01, HEXAGONS 50x43,3 CM
CP-5 : VOXFLO, PRISM 33, HEXAGONS 50x43,3 CM
CP-6 : VOXFLO, CRYSTAL 04 HEXAGONS 50x43,3 CM
CP-7 : VOXFLO, CRYSTAL 10 HEXAGONS 50x43,3 CM

MT-1 : STAINLESS STEEL HAIRLINE H 80 MM
MT-2 : POWDER COATING METAL, BLACK, DOFF
MT-3 : POWDER COATING METAL, WHITE, DOFF

PT-1 : PAINT, DULUX XXX

SP-1 : SPRAY PAINT (DUCO) YELLOW
SP-2 : SPRAY PAINT (DUCO) BLUE
SP-3 : SPRAY PAINT (DUCO) TOSCA

FB-1 : FABRIC, ATEJA LORENZIA, FESTUS 160
FB-2 : FABRIC, ATEJA LORENZIA,
COLOR MATCH TO LM-4
FB-3 : FABRIC, VANIA, FORTE

GL-1 : CLEAR GLASS

BG-1 : BACKPAINTED GLASS, HIMALAYA ABADI -
GLASSTONE - SUPER WHITE

LM-1 : HPL, AICA AS-14062CS83 LIGHTGRAY LEGER
STONE
LM-2 : HPL, CARTA CT 7878 T ARGENTINA CHERRY
LM-3 : HPL, TACO TH 006 AA MIDNIGHT GREY
LM-4 : HPL, TACO TH 021 AA CANARY YELLOW

SF-1 : STICKER PRINTING, DOFF
SF-2 : ACRYLIC LASER CU FIN. IN SPRAY PAINT, DOFF
SF-3 : GRADATION STICKER ONE SIDE - WHITE
SF-4 : STICKER FILM GREY 40%

Bintaro Business Centre Building
Jl. RC Veteran No. 1-1 Bintaro
Phone: +62 21 7357679
Fax: +62 21 7433946
www.dezanstudio.com
admin@dezanstudio.com

CLIENT

UNDP


PROJECT

2019 - UNDP PROJECT 3A


DRAWING TITLE

SECTION F & G

DRAWING No.	REVISION
INT-116	REV A
SCALE 1:50 @A3	CHECKED AS
DATE November 5, 2020	DRAWN AS

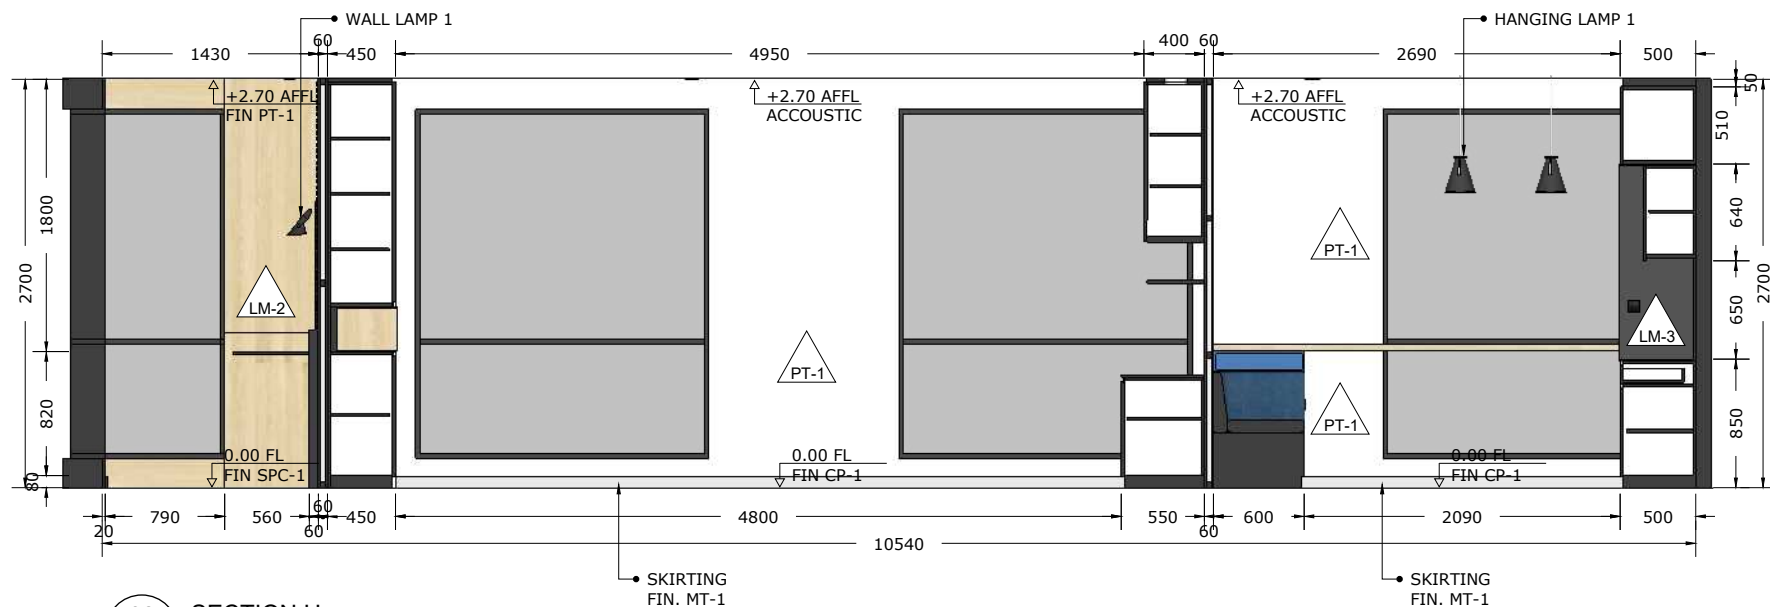

02 SECTION H
INT-117 Scale: 1:50

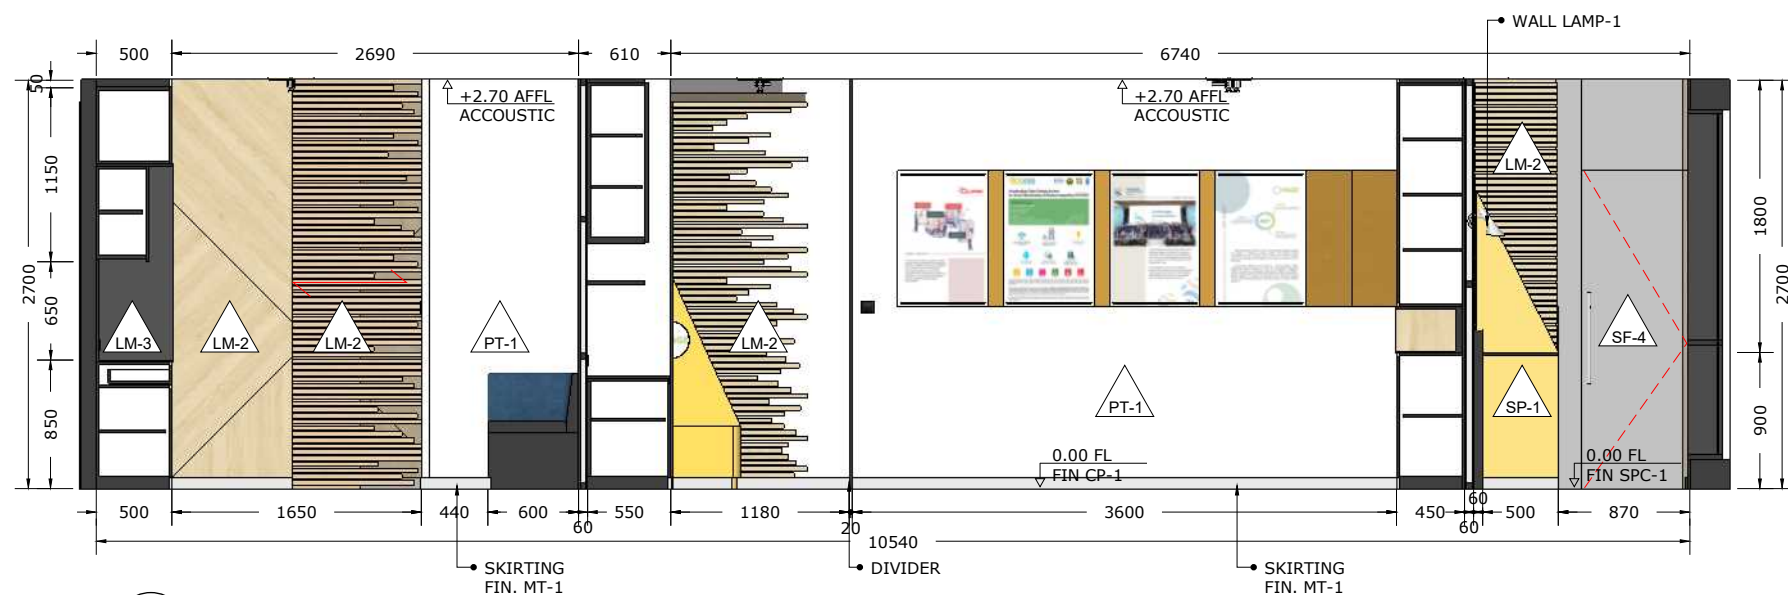

03 SECTION I
INT-117 Scale: 1:50



01 KEYPLAN
INT-117 Scale: 1:200

- NOTE :
- SPC-1 : SPC FLOOR, PATINA, LEMON
SPC-2 : PATINA, SKIRTING 80
- CP-1 : SMJ CARPET, BLUESTONE, TIMELESS GREY 50 X 50 CM
CP-2 : SMJ CARPET, CONCEPT LOOP, BLUE SCREEN 50 X 50 CM
CP-3 : SMJ CARPET, COLOR BOX, YELLOW LEMON 50 X 50 CM
CP-4 : VOXFLO, PRISM 01, HEXAGONS 50x43,3 CM
CP-5 : VOXFLO, PRISM 33, HEXAGONS 50x43,3 CM
CP-6 : VOXFLO, CRYSTAL 04 HEXAGONS 50x43,3 CM
CP-7 : VOXFLO, CRYSTAL 10 HEXAGONS 50x43,3 CM
- MT-1 : STAINLESS STEEL HAIRLINE H 80 MM
MT-2 : POWDER COATING METAL, BLACK, DOFF
MT-3 : POWDER COATING METAL, WHITE, DOFF
- PT-1 : PAINT, DULUX XXX
- SP-1 : SPRAY PAINT (DUCO) YELLOW
SP-2 : SPRAY PAINT (DUCO) BLUE
SP-3 : SPRAY PAINT (DUCO) TOSCA
- FB-1 : FABRIC, ATEJA LORENZIA, FESTUS 160
FB-2 : FABRIC, ATEJA LORENZIA, COLOR MATCH TO LM-4
FB-3 : FABRIC, VANIA, FORTE
- GL-1 : CLEAR GLASS
- BG-1 : BACKPAINTED GLASS, HIMALAYA ABADI - GLASSTONE - SUPER WHITE
- LM-1 : HPL, AICA AS-14062CS83 LIGHTGRAY LEGER STONE
LM-2 : HPL, CARTA CT 7878 T ARGENTINA CHERRY
LM-3 : HPL, TACO TH 006 AA MIDNIGHT GREY
LM-4 : HPL, TACO TH 021 AA CANARY YELLOW
- SF-1 : STICKER PRINTING, DOFF
SF-2 : ACRYLIC LASER CU FIN. IN SPRAY PAINT, DOFF
SF-3 : GRADATION STICKER ONE SIDE - WHITE
SF-4 : STICKER FILM GREY 40%

DEZAN STUDIO
Bintaro Business Centre Building
Jl. RC Veteran No. 1-1 Bintaro
Phone: +62 21 7357679
Fax: +62 21 7433946
www.dezanstudio.com
admin@dezanstudio.com

CLIENT

UNDP


PROJECT

2019 - UNDP PROJECT 3A


DRAWING TITLE

SECTION H & I


DRAWING No.	REVISION
INT-117	REV A
SCALE 1:50 @A3	CHECKED AS
DATE November 5, 2020	DRAWN AS

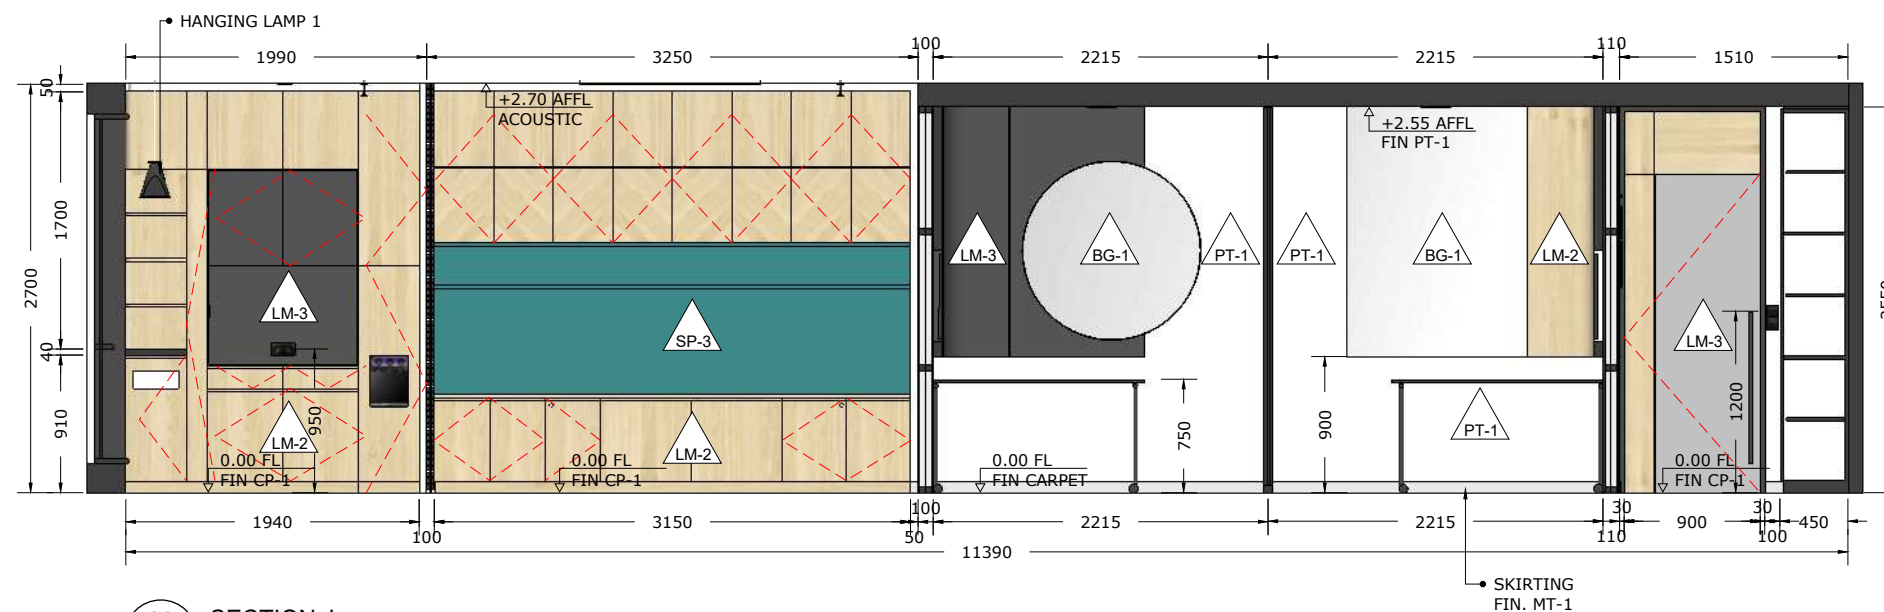

02 SECTION J
INT-118 Scale: 1:50

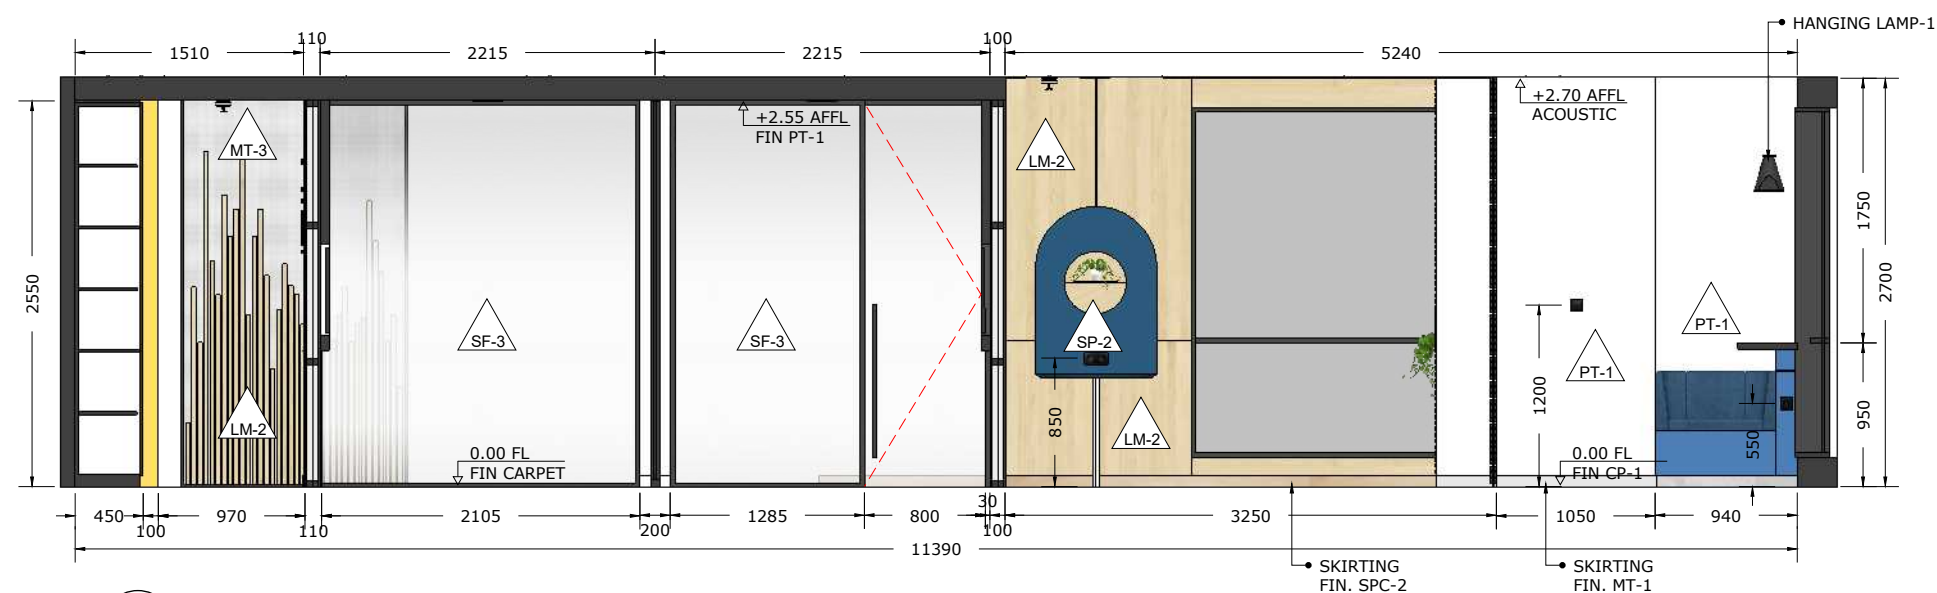

03 SECTION K
INT-118 Scale: 1:50

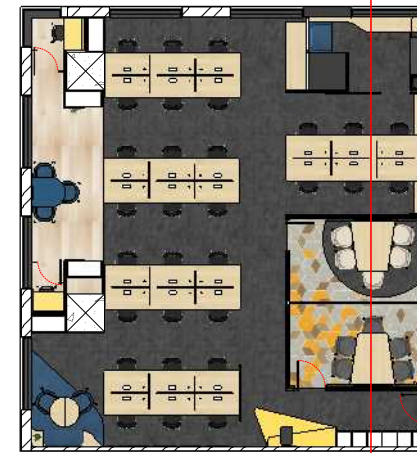

01 KEYPLAN
INT-118 Scale: 1:200

- NOTE :
- SPC-1 : SPC FLOOR, PATINA, LEMON
SPC-2 : PATINA, SKIRTING 80
- CP-1 : SMJ CARPET, BLUESTONE, TIMELESS GREY 50 X 50 CM
CP-2 : SMJ CARPET, CONCEPT LOOP, BLUE SCREEN 50 X 50 CM
CP-3 : SMJ CARPET, COLOR BOX, YELLOW LEMON 50 X 50 CM
CP-4 : VOXFLO, PRISM 01, HEXAGONS 50x43,3 CM
CP-5 : VOXFLO, PRISM 33, HEXAGONS 50x43,3 CM
CP-6 : VOXFLO, CRYSTAL 04 HEXAGONS 50x43,3 CM
CP-7 : VOXFLO, CRYSTAL 10 HEXAGONS 50x43,3 CM
- MT-1 : STAINLESS STEEL HAIRLINE H 80 MM
MT-2 : POWDER COATING METAL, BLACK, DOFF
MT-3 : POWDER COATING METAL, WHITE, DOFF
- PT-1 : PAINT, DULUX XXX
- SP-1 : SPRAY PAINT (DUCO) YELLOW
SP-2 : SPRAY PAINT (DUCO) BLUE
SP-3 : SPRAY PAINT (DUCO) TOSCA
- FB-1 : FABRIC, ATEJA LORENZIA, FESTUS 160
FB-2 : FABRIC, ATEJA LORENZIA, COLOR MATCH TO LM-4
FB-3 : FABRIC, VANIA, FORTE
- GL-1 : CLEAR GLASS
- BG-1 : BACKPAINTED GLASS, HIMALAYA ABADI - GLASSTONE - SUPER WHITE
- LM-1 : HPL, AICA AS-14062CS83 LIGHTGRAY LEGER STONE
LM-2 : HPL, CARTA CT 7878 T ARGENTINA CHERRY
LM-3 : HPL, TACO TH 006 AA MIDNIGHT GREY
LM-4 : HPL, TACO TH 021 AA CANARY YELLOW
- SF-1 : STICKER PRINTING, DOFF
SF-2 : ACRYLIC LASER CU FIN. IN SPRAY PAINT, DOFF
SF-3 : GRADATION STICKER ONE SIDE - WHITE
SF-4 : STICKER FILM GREY 40%

DEZAN STUDIO
Bintaro Business Centre Building
Jl. RC Veteran No. 1-1 Bintaro
Phone: +62 21 7357679
Fax: +62 21 7433946
www.dezanstudio.com
admin@dezanstudio.com

CLIENT

UNDP


PROJECT

2019 - UNDP PROJECT 3A


DRAWING TITLE

SECTION J & K

DRAWING No.	REVISION
INT-118	REV A
SCALE 1:50 @A3	CHECKED AS
DATE November 5, 2020	DRAWN AS

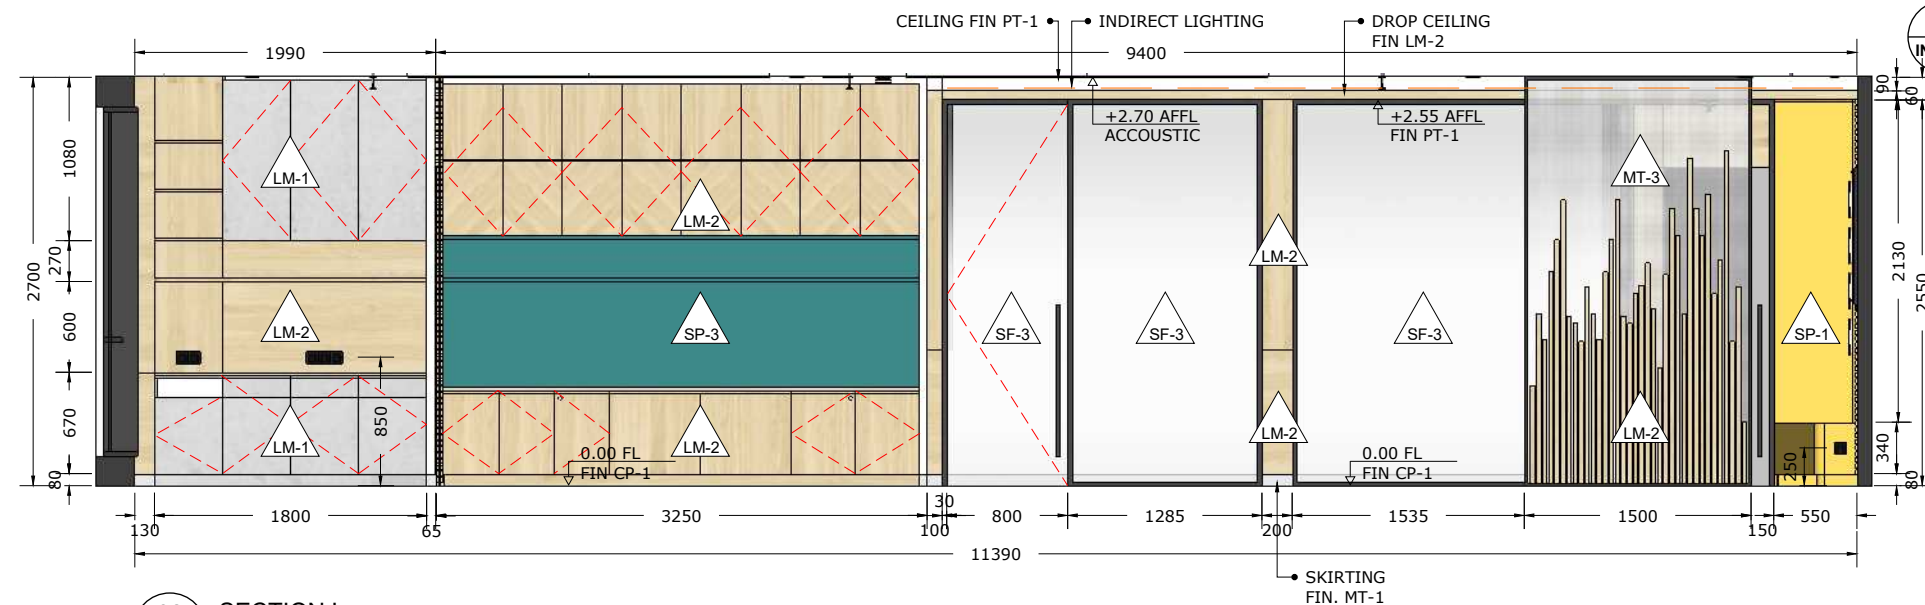

02 SECTION L
INT-119 Scale: 1:50

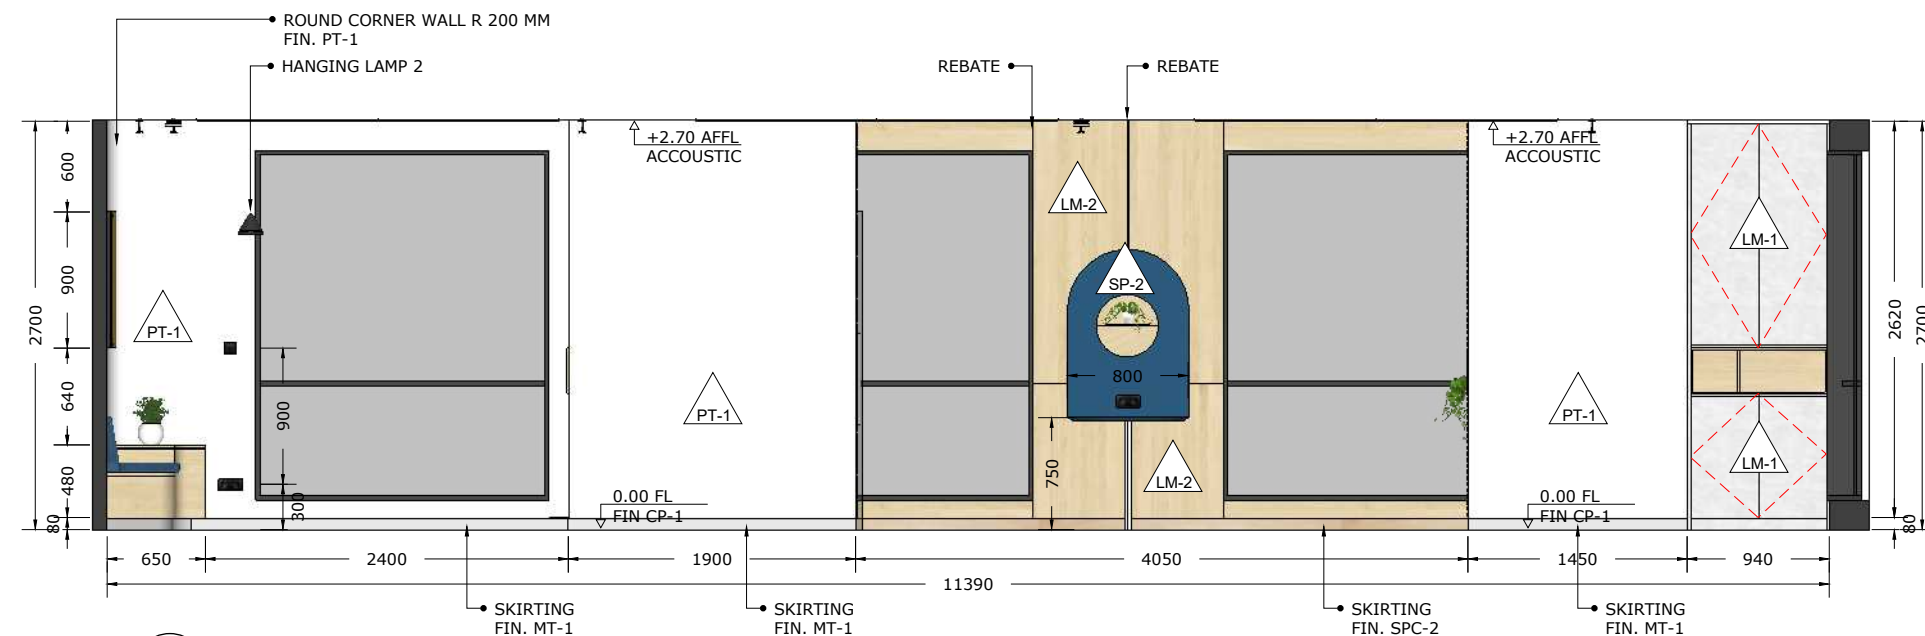

03 SECTION M
INT-119 Scale: 1:50



01 KEYPLAN
Scale: 1:200

- NOTE :
- SPC-1 : SPC FLOOR, PATINA, LEMON
SPC-2 : PATINA, SKIRTING 80
- CP-1 : SMJ CARPET, BLUESTONE, TIMELESS GREY 50 X 50 CM
CP-2 : SMJ CARPET, CONCEPT LOOP, BLUE SCREEN 50 X 50 CM
CP-3 : SMJ CARPET, COLOR BOX, YELLOW LEMON 50 X 50 CM
CP-4 : VOXFLO, PRISM 01, HEXAGONS 50x43,3 CM
CP-5 : VOXFLO, PRISM 33, HEXAGONS 50x43,3 CM
CP-6 : VOXFLO, CRYSTAL 04 HEXAGONS 50x43,3 CM
CP-7 : VOXFLO, CRYSTAL 10 HEXAGONS 50x43,3 CM
- MT-1 : STAINLESS STEEL HAIRLINE H 80 MM
MT-2 : POWDER COATING METAL, BLACK, DOFF
MT-3 : POWDER COATING METAL, WHITE, DOFF
- PT-1 : PAINT, DULUX XXX
- SP-1 : SPRAY PAINT (DUCCO) YELLOW
SP-2 : SPRAY PAINT (DUCCO) BLUE
SP-3 : SPRAY PAINT (DUCCO) TOSCA
- FB-1 : FABRIC, ATEJA LORENZIA, FESTUS 160
FB-2 : FABRIC, ATEJA LORENZIA, COLOR MATCH TO LM-4
FB-3 : FABRIC, VANIA, FORTE
- GL-1 : CLEAR GLASS
- BG-1 : BACKPAINTED GLASS, HIMALAYA ABADI - GLASSTONE - SUPER WHITE
- LM-1 : HPL, AICA AS-14062CS83 LIGHTGRAY LEGER STONE
LM-2 : HPL, CARTA CT 7878 T ARGENTINA CHERRY
LM-3 : HPL, TACO TH 006 AA MIDNIGHT GREY
LM-4 : HPL, TACO TH 021 AA CANARY YELLOW
- SF-1 : STICKER PRINTING, DOFF
SF-2 : ACRYLIC LASER CU FIN. IN SPRAY PAINT, DOFF
SF-3 : GRADATION STICKER ONE SIDE - WHITE
SF-4 : STICKER FILM GREY 40%

DEZAN STUDIO
Bintaro Business Centre Building
Jl. RC Veteran No. 1-1 Bintaro
Phone: +62 21 7357679
Fax: +62 21 7433946
www.dezanstudio.com
admin@dezanstudio.com

CLIENT

UNDP


PROJECT

2019 - UNDP PROJECT 3A


DRAWING TITLE

SECTION L & M

DRAWING No.	REVISION
INT-119	REV A
SCALE 1:50 @A3	CHECKED AS
DATE November 5, 2020	DRAWN AS

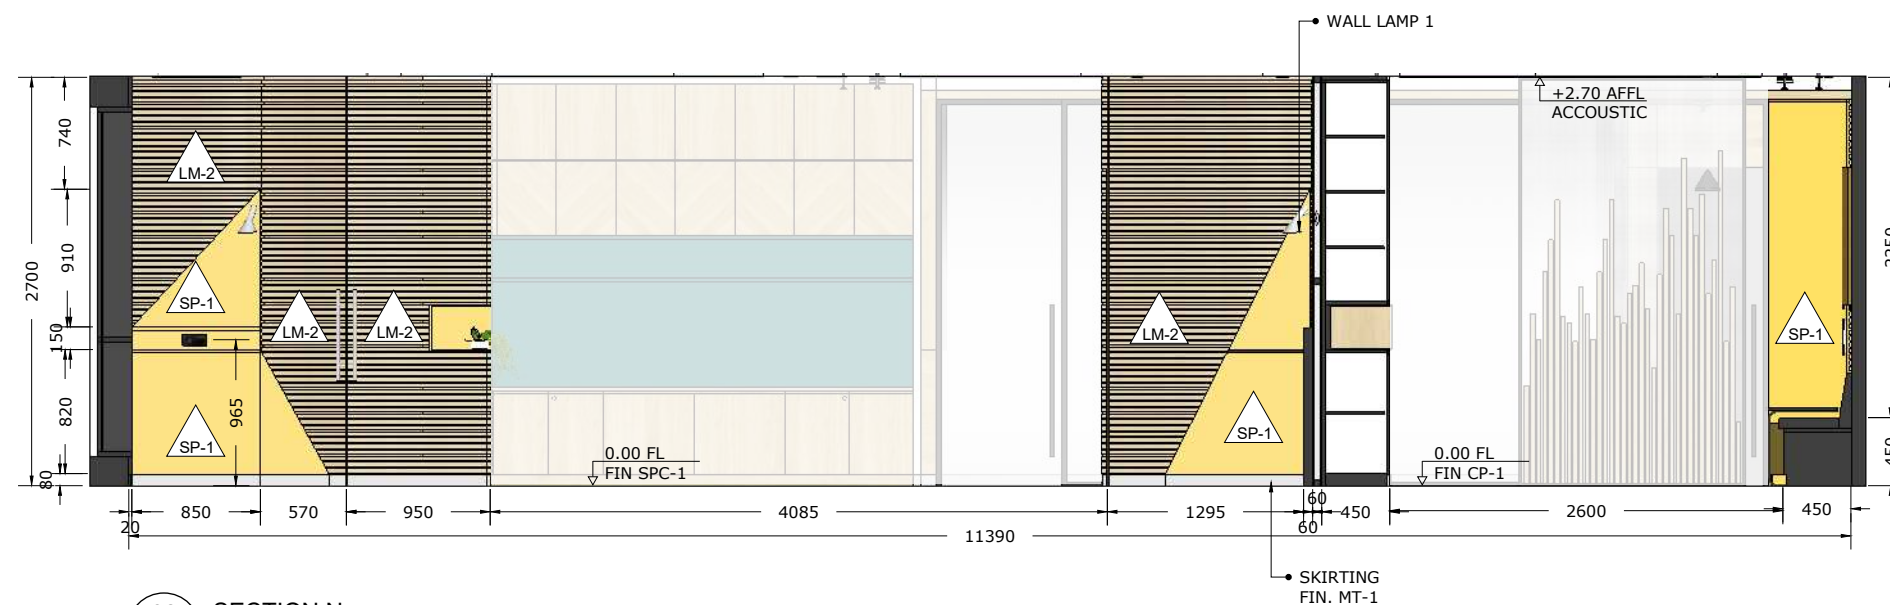

02 SECTION N
INT-120 Scale: 1:50

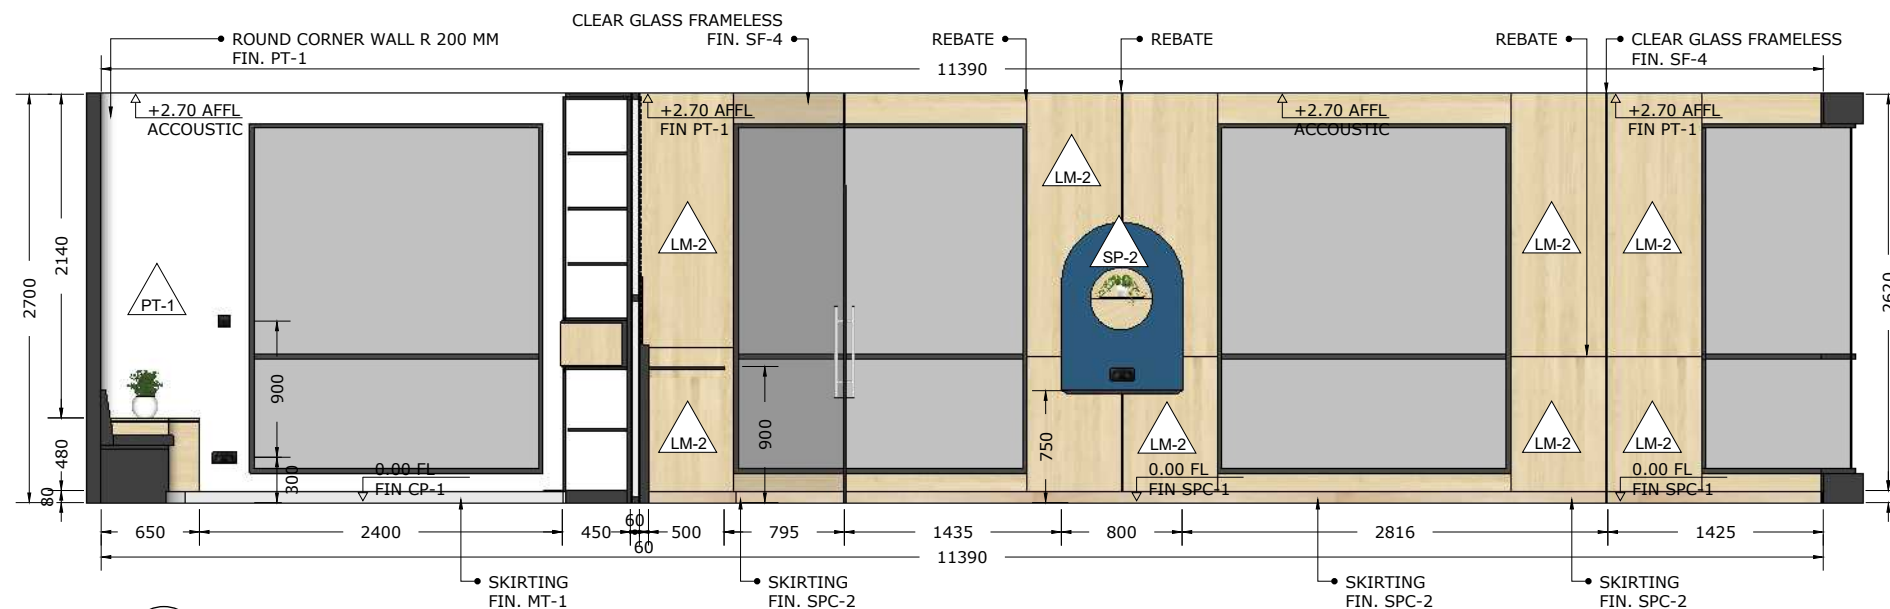

03 SECTION O
INT-120 Scale: 1:50



01 KEYPLAN
INT-120 Scale: 1:200

- NOTE :
- SPC-1 : SPC FLOOR, PATINA, LEMON
SPC-2 : PATINA, SKIRTING 80
- CP-1 : SMJ CARPET, BLUESTONE, TIMELESS GREY 50 X 50 CM
CP-2 : SMJ CARPET, CONCEPT LOOP, BLUE SCREEN 50 X 50 CM
CP-3 : SMJ CARPET, COLOR BOX, YELLOW LEMON 50 X 50 CM
CP-4 : VOXFLO, PRISM 01, HEXAGONS 50x43,3 CM
CP-5 : VOXFLO, PRISM 33, HEXAGONS 50x43,3 CM
CP-6 : VOXFLO, CRYSTAL 04 HEXAGONS 50x43,3 CM
CP-7 : VOXFLO, CRYSTAL 10 HEXAGONS 50x43,3 CM
- MT-1 : STAINLESS STEEL HAIRLINE H 80 MM
MT-2 : POWDER COATING METAL, BLACK, DOFF
MT-3 : POWDER COATING METAL, WHITE, DOFF
- PT-1 : PAINT, DULUX XXX
- SP-1 : SPRAY PAINT (DUCO) YELLOW
SP-2 : SPRAY PAINT (DUCO) BLUE
SP-3 : SPRAY PAINT (DUCO) TOSCA
- FB-1 : FABRIC, ATEJA LORENZIA, FESTUS 160
FB-2 : FABRIC, ATEJA LORENZIA, COLOR MATCH TO LM-4
FB-3 : FABRIC, VANIA, FORTE
- GL-1 : CLEAR GLASS
- BG-1 : BACKPAINTED GLASS, HIMALAYA ABADI - GLASSTONE - SUPER WHITE
- LM-1 : HPL, AICA AS-14062CS83 LIGHTGRAY LEGER STONE
LM-2 : HPL, CARTA CT 7878 T ARGENTINA CHERRY
LM-3 : HPL, TACO TH 006 AA MIDNIGHT GREY
LM-4 : HPL, TACO TH 021 AA CANARY YELLOW
- SF-1 : STICKER PRINTING, DOFF
SF-2 : ACRYLIC LASER CU FIN. IN SPRAY PAINT, DOFF
SF-3 : GRADATION STICKER ONE SIDE - WHITE
SF-4 : STICKER FILM GREY 40%

Bintaro Business Centre Building
Jl. RC Veteran No. 1-1 Bintaro
Phone: +62 21 7357679
Fax: +62 21 7433946
www.dezanstudio.com
admin@dezanstudio.com

CLIENT

UNDP


PROJECT

2019 - UNDP PROJECT 3A


DRAWING TITLE

SECTION N & O


DRAWING No.	REVISION
INT-120	REV A
SCALE 1:50 @A3	CHECKED AS
DATE November 5, 2020	DRAWN AS

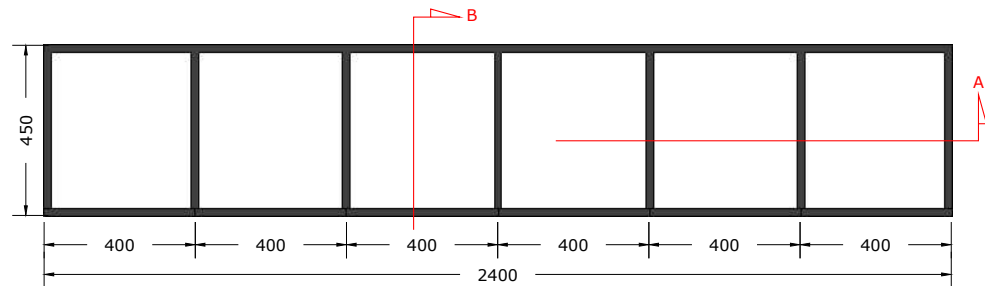


03 TOP VIEW
INT-121 Scale: 1:20

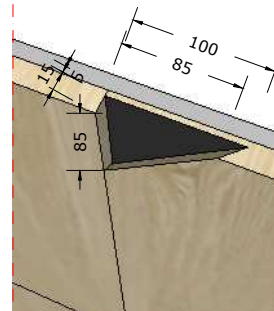


07 DETAIL HANDGROOVE
INT-121 Scale: NTS

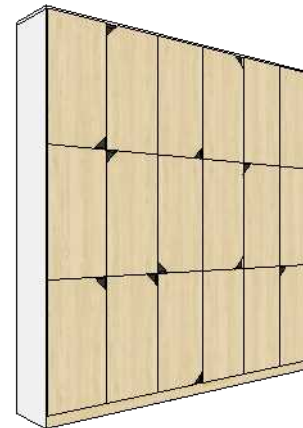


02 C-1 FILING CABINET 1
INT-121 Scale: NTS

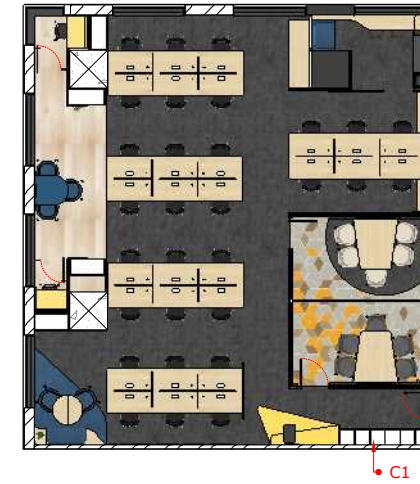


01 KEYPLAN
INT-121 Scale: 1:200

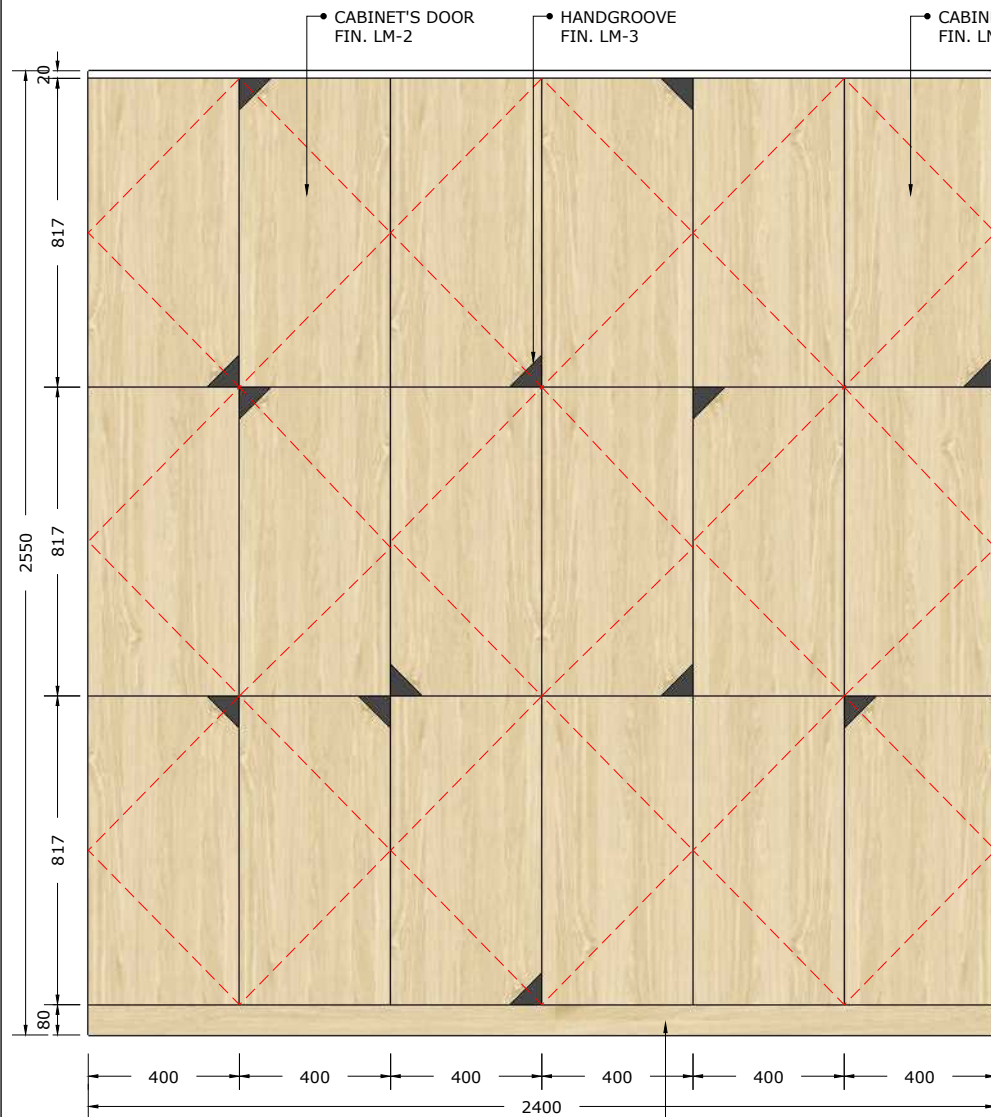

04 FRONT VIEW
INT-121 Scale: 1:20

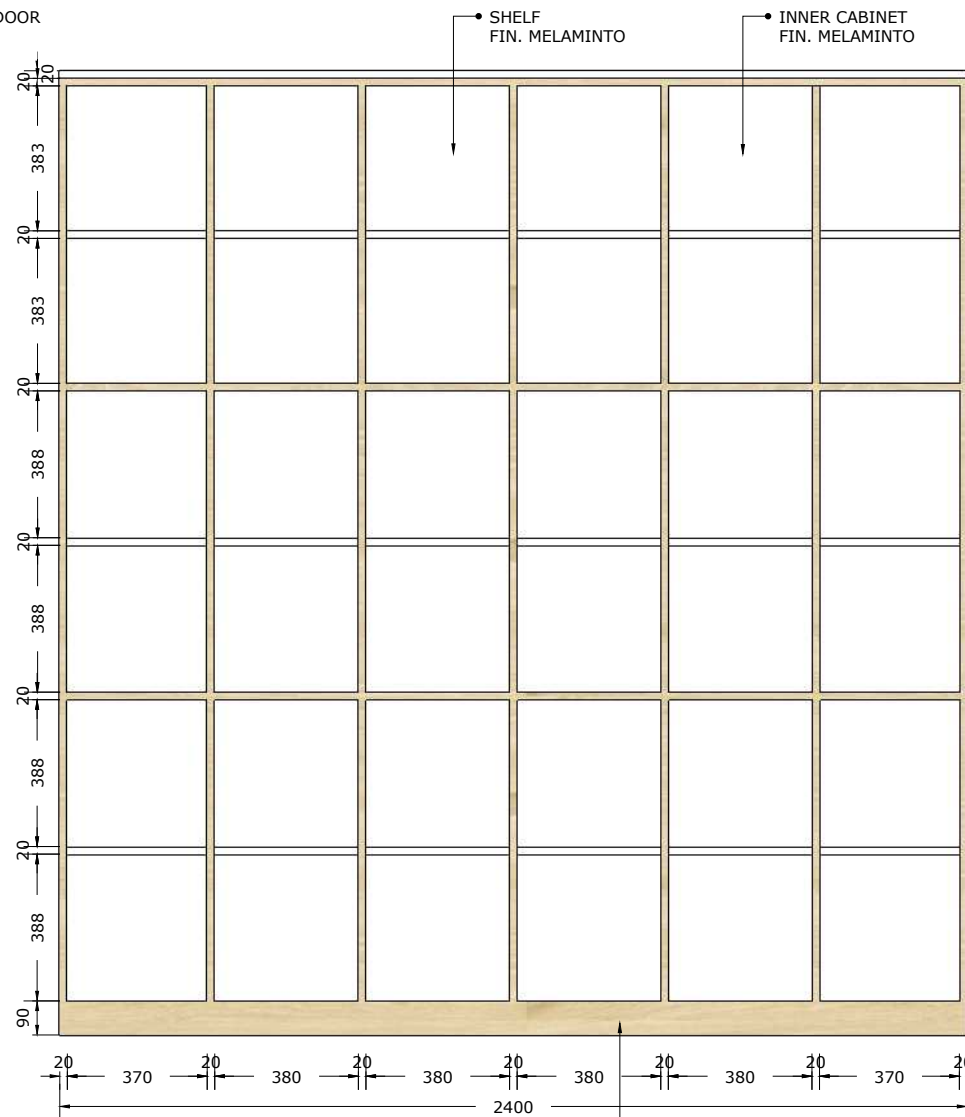

05 SECTION A
INT-121 Scale: 1:20



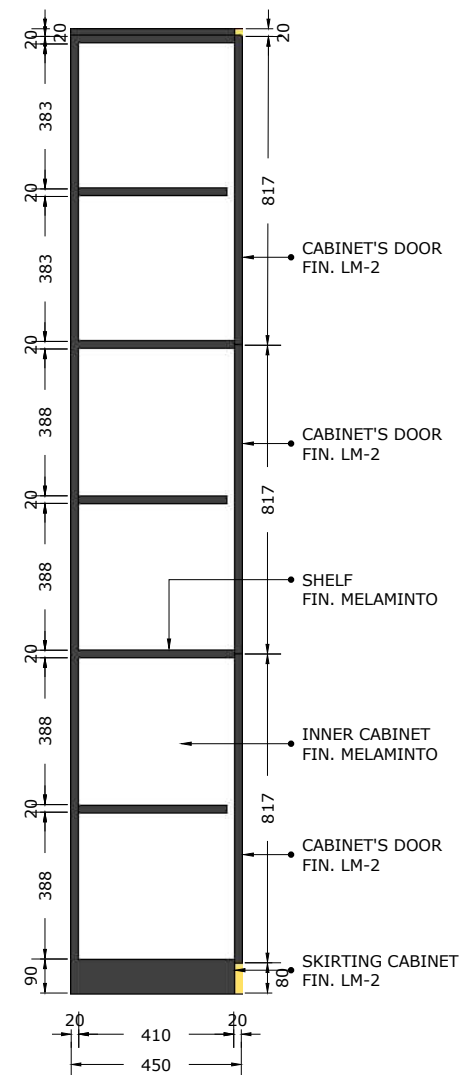


06 SECTION B
INT-121 Scale: 1:20

- NOTE :
- SPC-1 : SPC FLOOR, PATINA, LEMON
SPC-2 : PATINA, SKIRTING 80
- CP-1 : SMJ CARPET, BLUESTONE, TIMELESS GREY 50 X 50 CM
CP-2 : SMJ CARPET, CONCEPT LOOP, BLUE SCREEN 50 X 50 CM
CP-3 : SMJ CARPET, COLOR BOX, YELLOW LEMON 50 X 50 CM
CP-4 : VOXFLO, PRISM 01, HEXAGONS 50x43,3 CM
CP-5 : VOXFLO, PRISM 33, HEXAGONS 50x43,3 CM
CP-6 : VOXFLO, CRYSTAL 04 HEXAGONS 50x43,3 CM
CP-7 : VOXFLO, CRYSTAL 10 HEXAGONS 50x43,3 CM
- MT-1 : STAINLESS STEEL HAIRLINE H 80 MM
MT-2 : POWDER COATING METAL, BLACK, DOFF
MT-3 : POWDER COATING METAL, WHITE, DOFF
- PT-1 : PAINT, DULUX XXX
- SP-1 : SPRAY PAINT (DUCO) YELLOW
SP-2 : SPRAY PAINT (DUCO) BLUE
SP-3 : SPRAY PAINT (DUCO) TOSCA
- FB-1 : FABRIC, ATEJA LORENZIA, FESTUS 160
FB-2 : FABRIC, ATEJA LORENZIA, COLOR MATCH TO LM-4
FB-3 : FABRIC, VANIA, FORTE
- GL-1 : CLEAR GLASS
- BG-1 : BACKPAINTED GLASS, HIMALAYA ABADI - GLASSTONE - SUPER WHITE
- LM-1 : HPL, AICA AS-14062CS83 LIGHTGRAY LEGER STONE
LM-2 : HPL, CARTA CT 7878 T ARGENTINA CHERRY
LM-3 : HPL, TACO TH 006 AA MIDNIGHT GREY
LM-4 : HPL, TACO TH 021 AA CANARY YELLOW
- SF-1 : STICKER PRINTING, DOFF
SF-2 : ACRYLIC LASER CU FIN. IN SPRAY PAINT, DOFF
SF-3 : GRADATION STICKER ONE SIDE - WHITE
SF-4 : STICKER FILM GREY 40%

Bintaro Business Centre Building
Jl. RC Veteran No. 1-1 Bintaro
Phone: +62 21 7357679
Fax: +62 21 7433946
www.dezanstudio.com
admin@dezanstudio.com



CLIENT	
UNDP	
PROJECT	
2019 - UNDP PROJECT 3A	
DRAWING TITLE	
C-1 FILING CABINET 1	
DRAWING No.	REVISION
INT-121	REV A
SCALE 1:20 @A3	CHECKED AS
DATE November 5, 2020	DRAWN AS

   


 **DEZAN**
STUDIO

Bintaro Business Centre Building
Jl. RC Veteran No. 1-1 Bintaro
Phone: +62 21 7357679
Fax: +62 21 7433946

  
www.dezanstudio.com
admin@dezanstudio.com




CLIENT	
UNDP	
PROJECT	
2019 - UNDP PROJECT 3A	
DRAWING TITLE	
C-2 FILING CABINET 2	
DRAWING No.	REVISION
INT-122	REV A
SCALE 1:20 @A3	CHECKED AS
DATE November 5, 2020	DRAWN AS

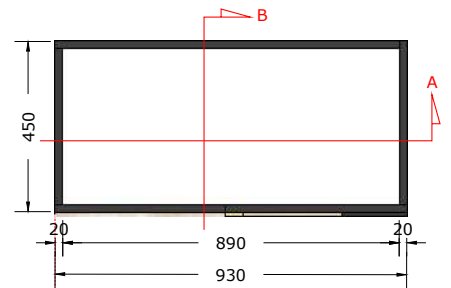


03 TOP VIEW
INT-123 Scale: 1:20

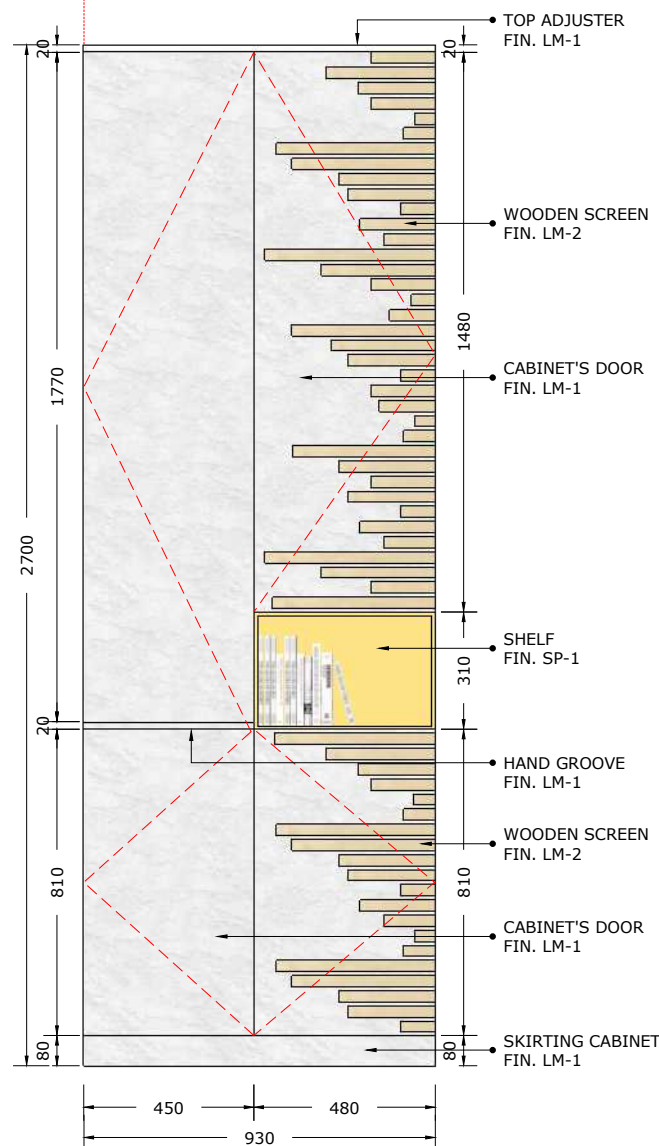


04 FRONT VIEW
INT-123 Scale: 1:20

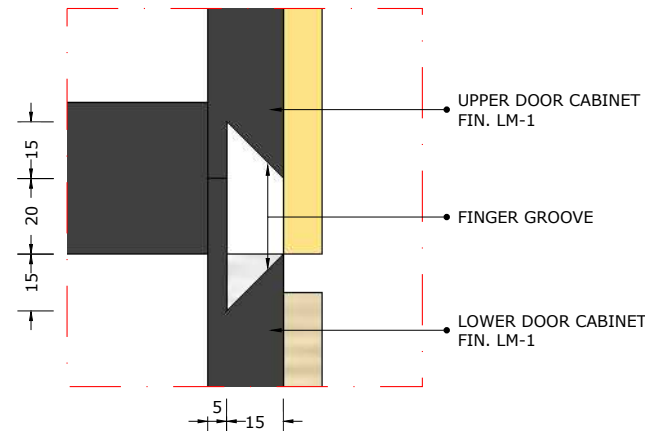


07 DETAIL 1 - HANDGROOVE
INT-123 Scale: 1:2

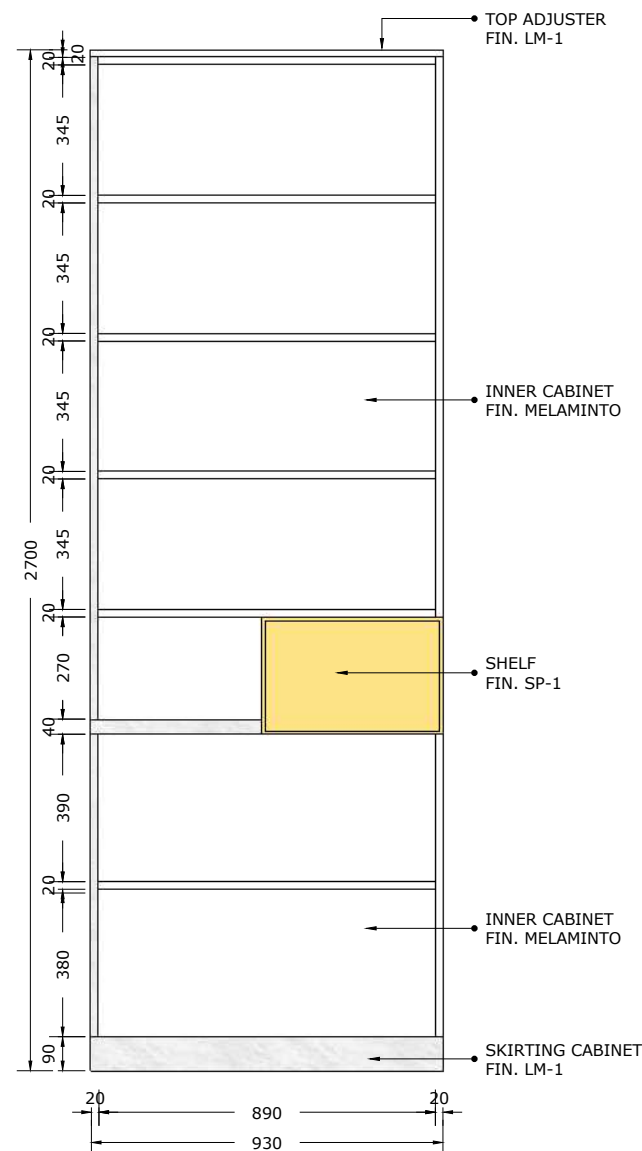


05 SECTION A
INT-123 Scale: 1:20

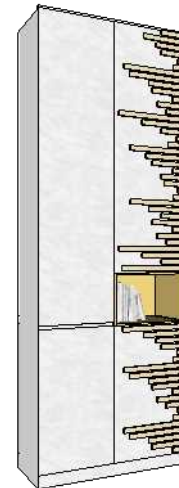

02 C-3 FILING CABINET 3
INT-123 Scale: NTS

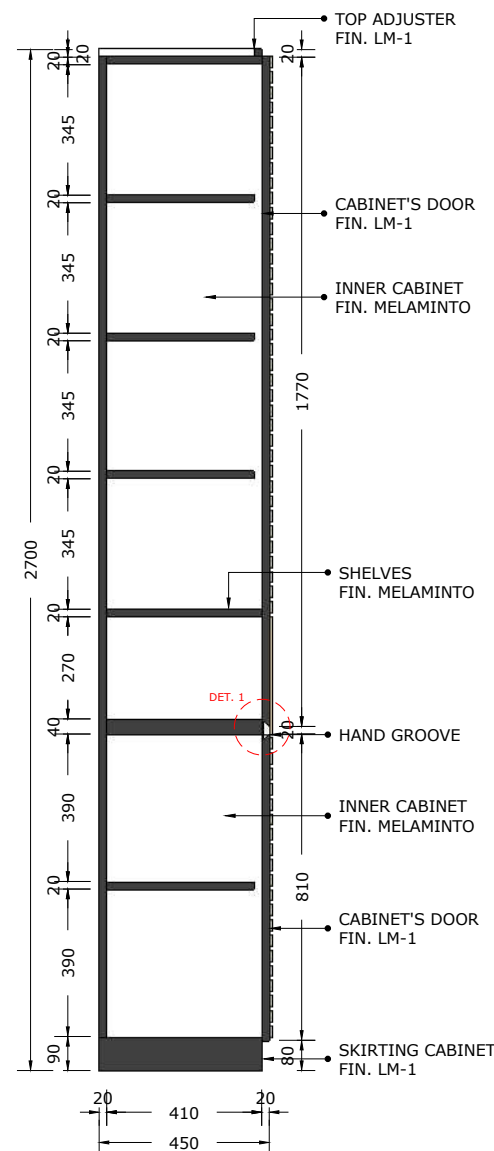

06 SECTION B
INT-123 Scale: 1:20

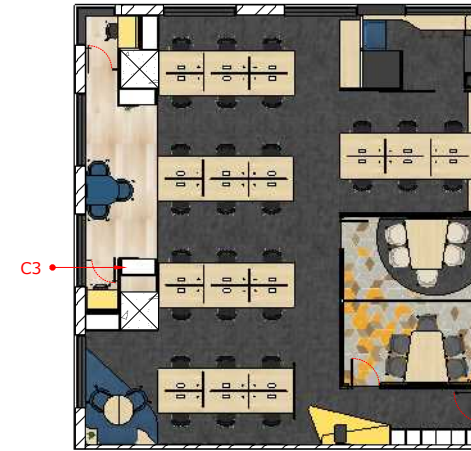

01 KEYPLAN
INT-123 Scale: 1:200

- NOTE :
- SPC-1 : SPC FLOOR, PATINA, LEMON
SPC-2 : PATINA, SKIRTING 80
- CP-1 : SMJ CARPET, BLUESTONE, TIMELESS GREY 50 X 50 CM
CP-2 : SMJ CARPET, CONCEPT LOOP, BLUE SCREEN 50 X 50 CM
CP-3 : SMJ CARPET, COLOR BOX, YELLOW LEMON 50 X 50 CM
CP-4 : VOXFLO, PRISM 01, HEXAGONS 50x43,3 CM
CP-5 : VOXFLO, PRISM 33, HEXAGONS 50x43,3 CM
CP-6 : VOXFLO, CRYSTAL 04 HEXAGONS 50x43,3 CM
CP-7 : VOXFLO, CRYSTAL 10 HEXAGONS 50x43,3 CM
- MT-1 : STAINLESS STEEL HAIRLINE H 80 MM
MT-2 : POWDER COATING METAL, BLACK, DOFF
MT-3 : POWDER COATING METAL, WHITE, DOFF
- PT-1 : PAINT, DULUX XXX
- SP-1 : SPRAY PAINT (DUCO) YELLOW
SP-2 : SPRAY PAINT (DUCO) BLUE
SP-3 : SPRAY PAINT (DUCO) TOSCA
- FB-1 : FABRIC, ATEJA LORENZIA, FESTUS 160
FB-2 : FABRIC, ATEJA LORENZIA, COLOR MATCH TO LM-4
FB-3 : FABRIC, VANIA, FORTE
- GL-1 : CLEAR GLASS
- BG-1 : BACKPAINTED GLASS, HIMALAYA ABADI - GLASSTONE - SUPER WHITE
- LM-1 : HPL, AICA AS-14062CS83 LIGHTGRAY LEGER STONE
LM-2 : HPL, CARTA CT 7878 T ARGENTINA CHERRY
LM-3 : HPL, TACO TH 006 AA MIDNIGHT GREY
LM-4 : HPL, TACO TH 021 AA CANARY YELLOW
- SF-1 : STICKER PRINTING, DOFF
SF-2 : ACRYLIC LASER CU FIN. IN SPRAY PAINT, DOFF
SF-3 : GRADATION STICKER ONE SIDE - WHITE
SF-4 : STICKER FILM GREY 40%

Bintaro Business Centre Building
Jl. RC Veteran No. 1-1 Bintaro
Phone: +62 21 7357679
Fax: +62 21 7433946
www.dezanstudio.com
admin@dezanstudio.com

CLIENT

UNDP


PROJECT

2019 - UNDP PROJECT 3A


DRAWING TITLE

C-3 FILING CABINET 3


DRAWING No.	REVISION
INT-123	REV A
SCALE 1:20 @A3	CHECKED AS
DATE November 5, 2020	DRAWN AS

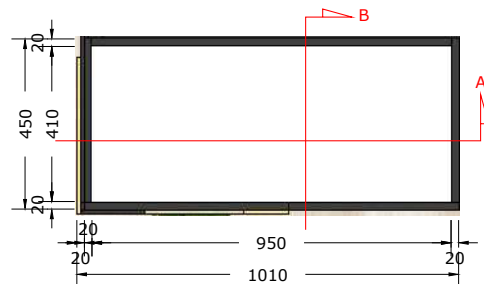


03 TOP VIEW
INT-124 Scale: 1:20

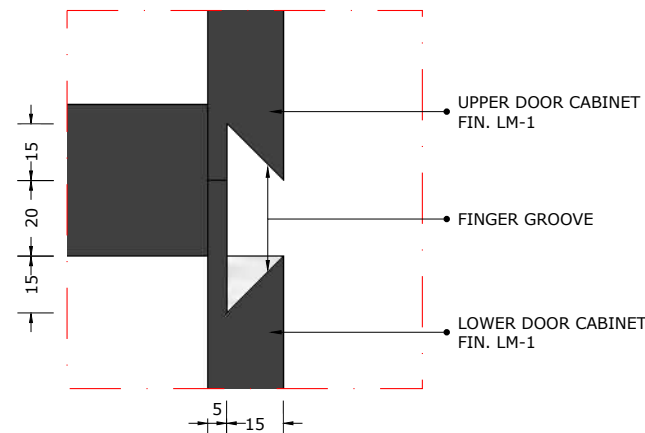


07 DETAIL 1 - HANDGROOVE
INT-124 Scale: 1:2

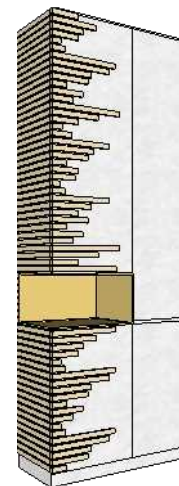


02 C-4 FILING CABINET 4
INT-124 Scale: NTS

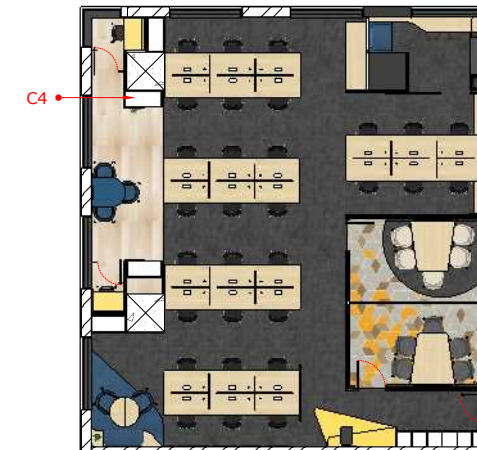


01 KEYPLAN
INT-124 Scale: 1:200

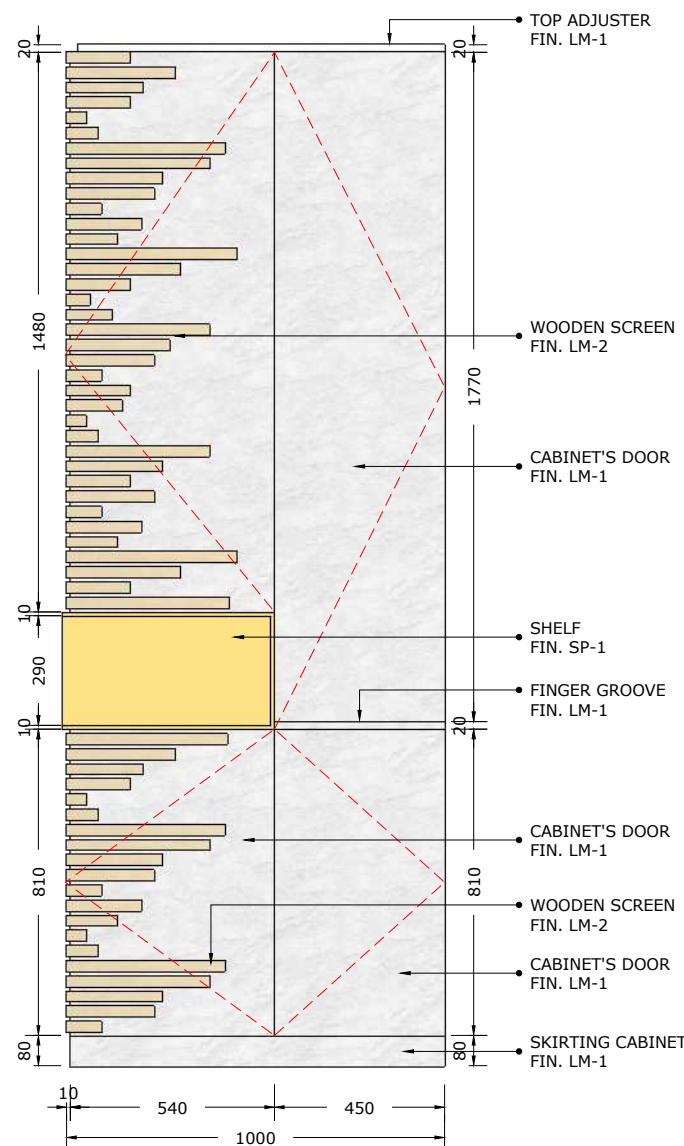

04 FRONT VIEW
INT-124 Scale: 1:20

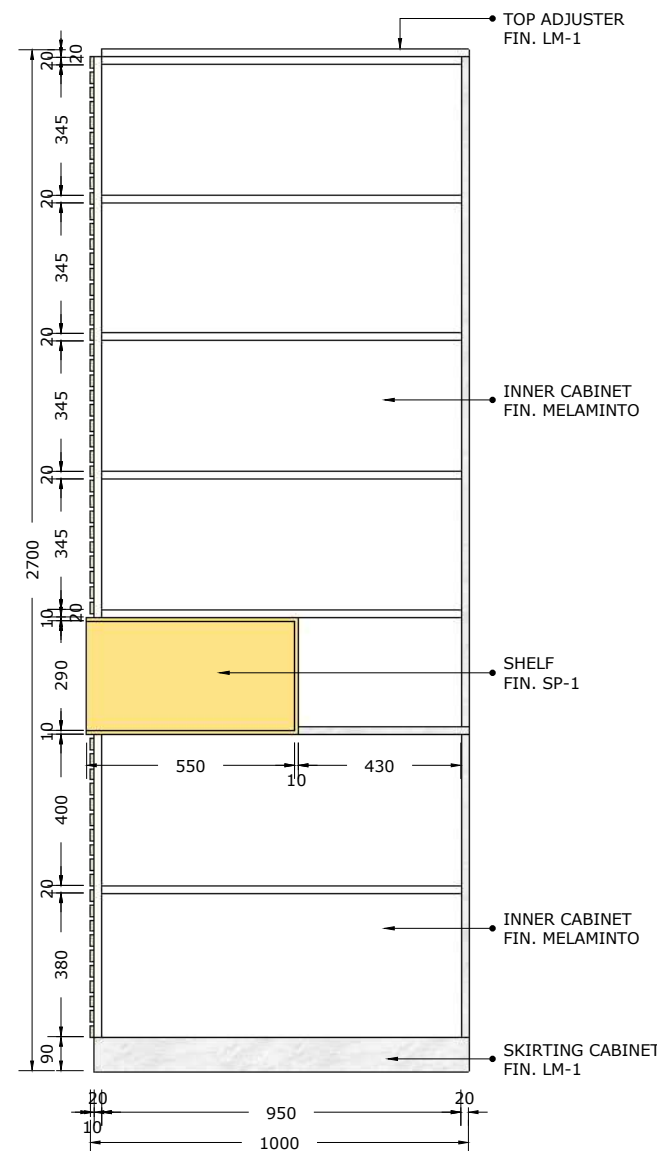

05 SECTION A
INT-124 Scale: 1:20

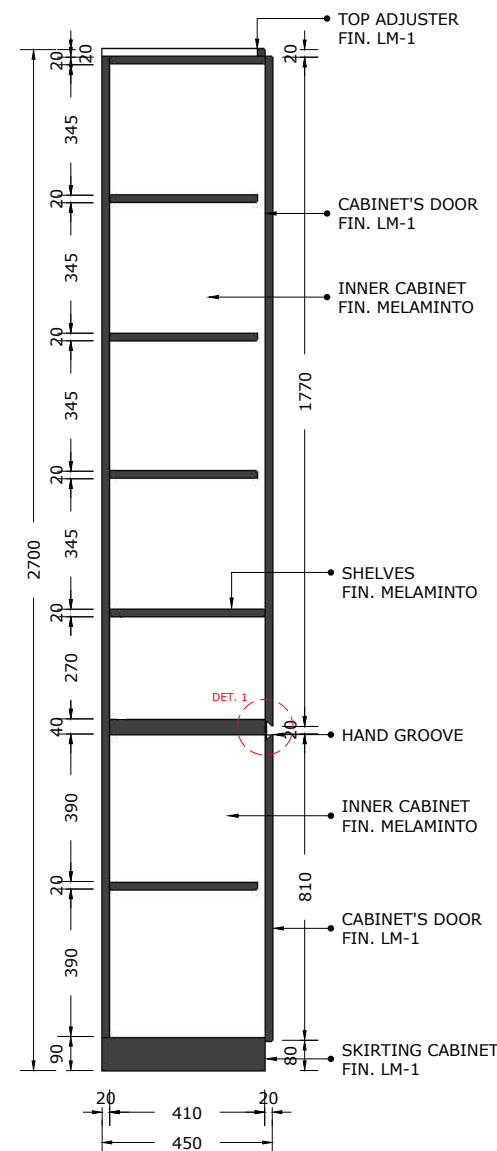

06 SECTION B
INT-124 Scale: 1:20

- NOTE :
- SPC-1 : SPC FLOOR, PATINA, LEMON
SPC-2 : PATINA, SKIRTING 80
- CP-1 : SMJ CARPET, BLUESTONE, TIMELESS GREY 50 X 50 CM
CP-2 : SMJ CARPET, CONCEPT LOOP, BLUE SCREEN 50 X 50 CM
CP-3 : SMJ CARPET, COLOR BOX, YELLOW LEMON 50 X 50 CM
CP-4 : VOXFLO, PRISM 01, HEXAGONS 50x43,3 CM
CP-5 : VOXFLO, PRISM 33, HEXAGONS 50x43,3 CM
CP-6 : VOXFLO, CRYSTAL 04 HEXAGONS 50x43,3 CM
CP-7 : VOXFLO, CRYSTAL 10 HEXAGONS 50x43,3 CM
- MT-1 : STAINLESS STEEL HAIRLINE H 80 MM
MT-2 : POWDER COATING METAL, BLACK, DOFF
MT-3 : POWDER COATING METAL, WHITE, DOFF
- PT-1 : PAINT, DULUX XXX
- SP-1 : SPRAY PAINT (DUCO) YELLOW
SP-2 : SPRAY PAINT (DUCO) BLUE
SP-3 : SPRAY PAINT (DUCO) TOSCA
- FB-1 : FABRIC, ATEJA LORENZIA, FESTUS 160
FB-2 : FABRIC, ATEJA LORENZIA, COLOR MATCH TO LM-4
FB-3 : FABRIC, VANIA, FORTE
- GL-1 : CLEAR GLASS
- BG-1 : BACKPAINTED GLASS, HIMALAYA ABADI - GLASSTONE - SUPER WHITE
- LM-1 : HPL, AICA AS-14062CS83 LIGHTGRAY LEGER STONE
LM-2 : HPL, CARTA CT 7878 T ARGENTINA CHERRY
LM-3 : HPL, TACO TH 006 AA MIDNIGHT GREY
LM-4 : HPL, TACO TH 021 AA CANARY YELLOW
- SF-1 : STICKER PRINTING, DOFF
SF-2 : ACRYLIC LASER CU FIN. IN SPRAY PAINT, DOFF
SF-3 : GRADATION STICKER ONE SIDE - WHITE
SF-4 : STICKER FILM GREY 40%

Bintaro Business Centre Building
Jl. RC Veteran No. 1-1 Bintaro
Phone: +62 21 7357679
Fax: +62 21 7433946
www.dezanstudio.com
admin@dezanstudio.com

CLIENT

UNDP

PROJECT

2019 - UNDP PROJECT 3A


DRAWING TITLE

C-4 FILING CABINET 4


DRAWING No.	REVISION
INT-124	REV A
SCALE 1:20 @A3	CHECKED AS
DATE November 5, 2020	DRAWN AS




03 TOP VIEW
INT-125 Scale: 1:20

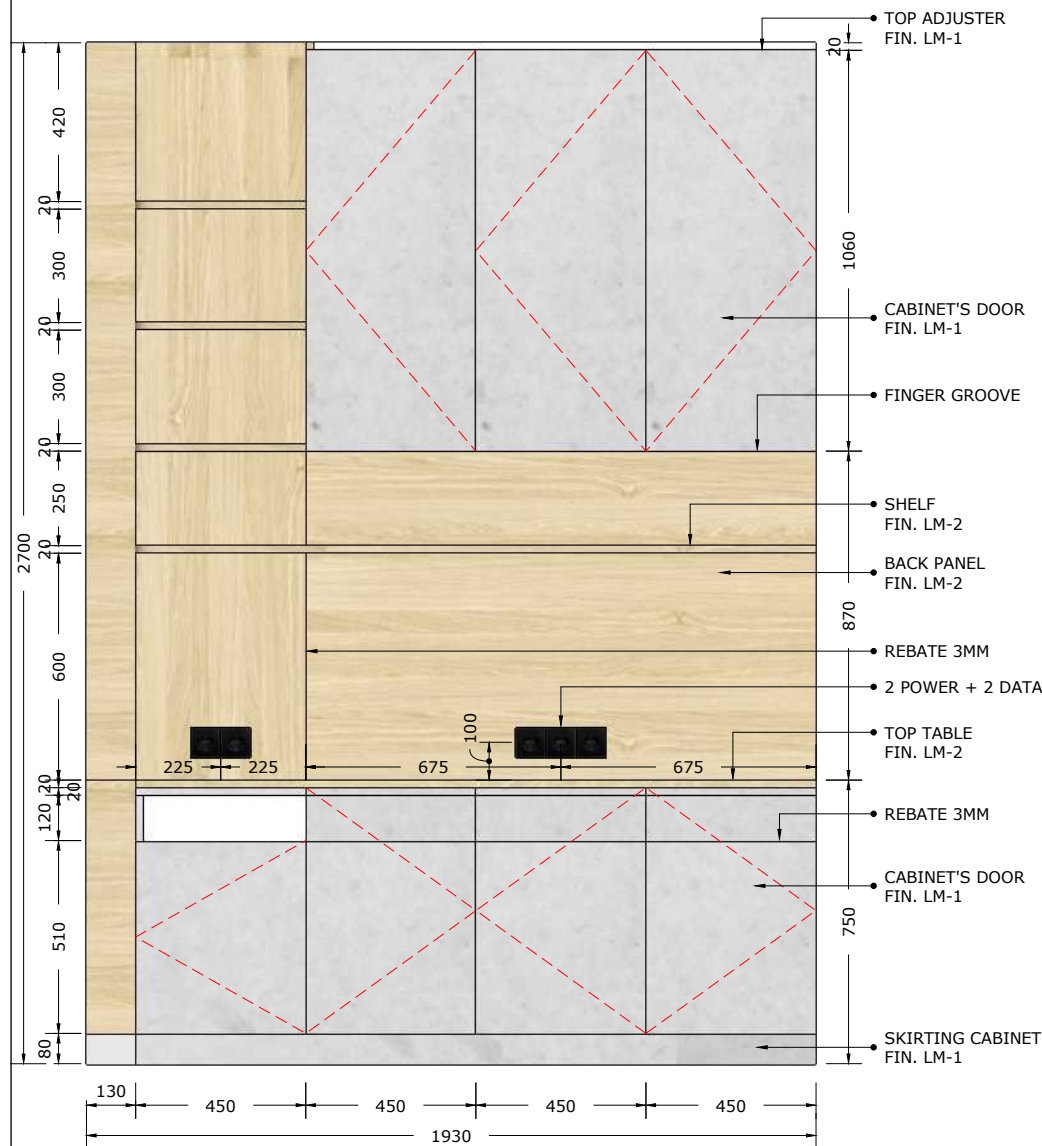


04 FRONT VIEW
INT-125 Scale: 1:20

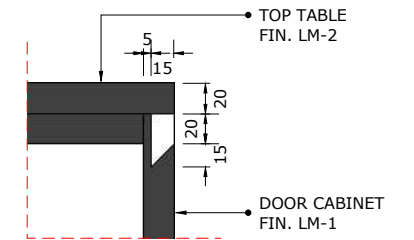

07 DETAIL 1
INT-125 Scale: 1:5

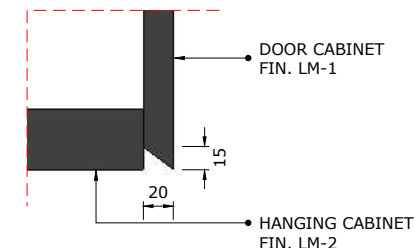


08 DETAIL 2
INT-125 Scale: 1:5

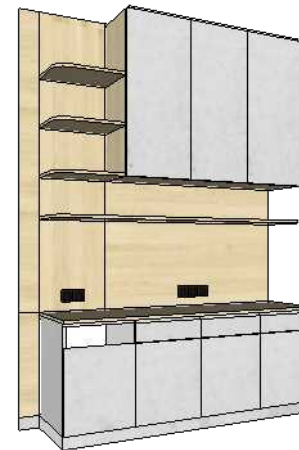


02 C-5 PRINTING CABINET
INT-125 Scale: NTS



01 KEYPLAN
INT-125 Scale: 1:200

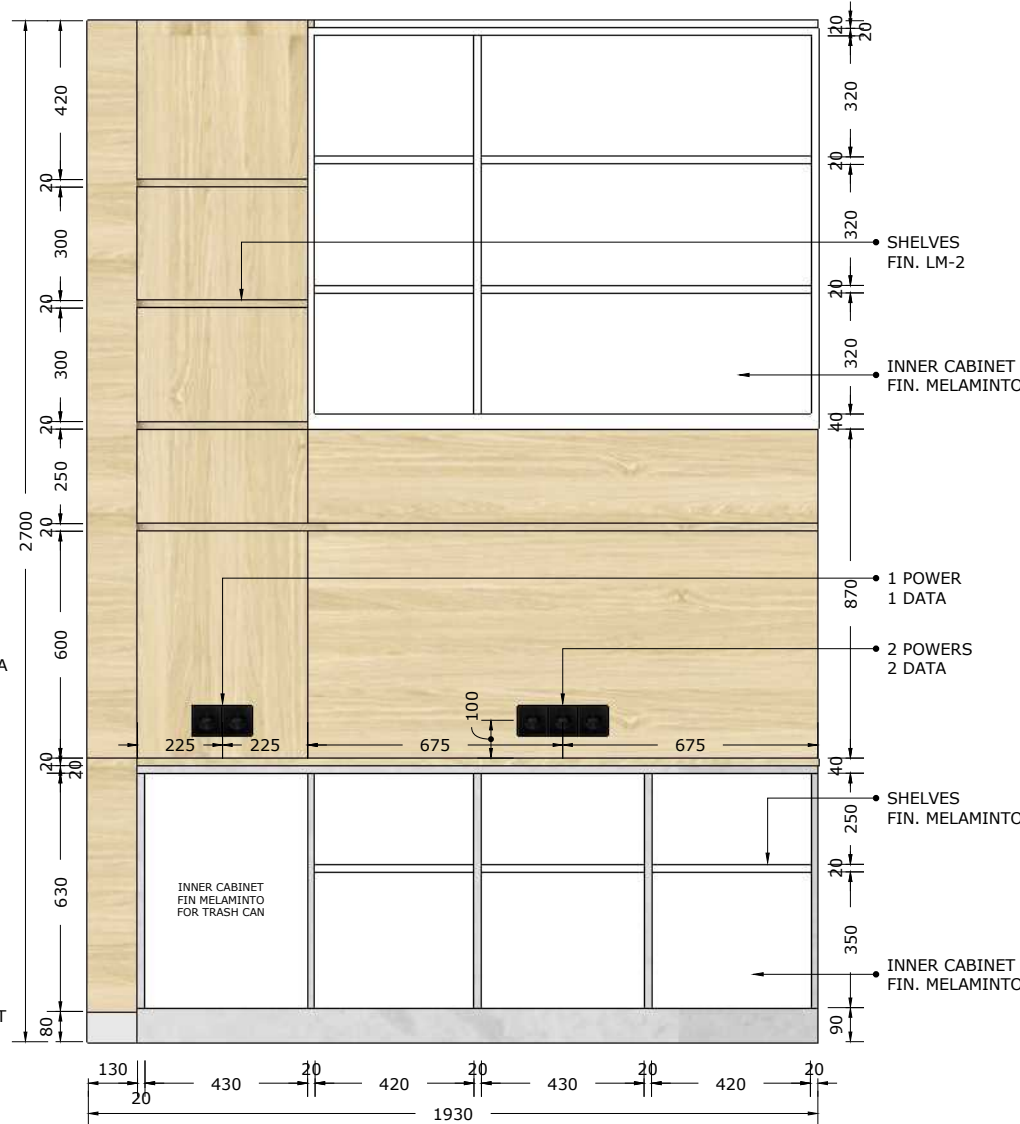

05 SECTION A
INT-125 Scale: 1:20

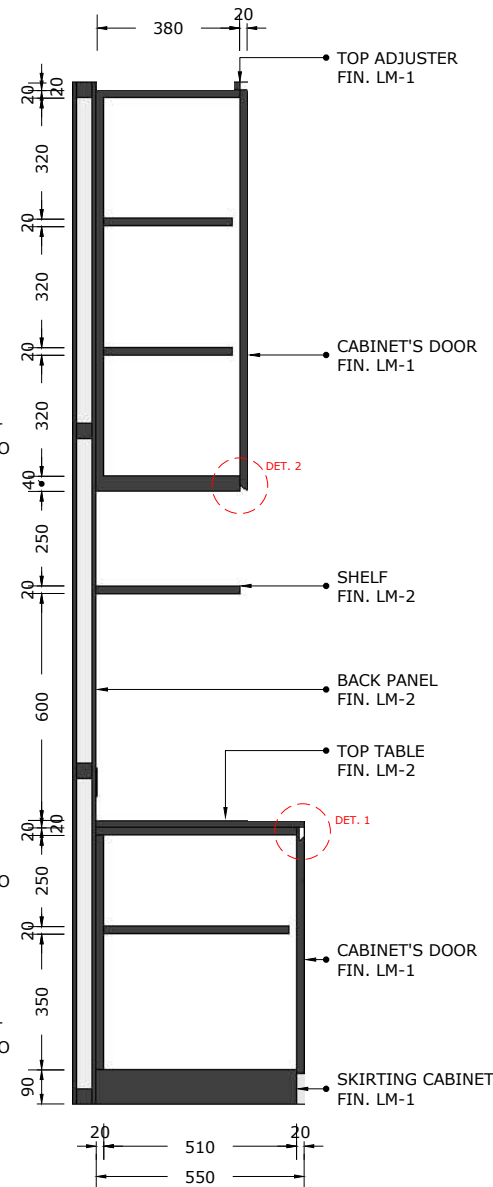

06 SECTION B
INT-125 Scale: 1:20

- NOTE :
- SPC-1 : SPC FLOOR, PATINA, LEMON
SPC-2 : PATINA, SKIRTING 80
- CP-1 : SMJ CARPET, BLUESTONE, TIMELESS GREY 50 X 50 CM
CP-2 : SMJ CARPET, CONCEPT LOOP, BLUE SCREEN 50 X 50 CM
CP-3 : SMJ CARPET, COLOR BOX, YELLOW LEMON 50 X 50 CM
CP-4 : VOXFLO, PRISM 01, HEXAGONS 50x43,3 CM
CP-5 : VOXFLO, PRISM 33, HEXAGONS 50x43,3 CM
CP-6 : VOXFLO, CRYSTAL 04 HEXAGONS 50x43,3 CM
CP-7 : VOXFLO, CRYSTAL 10 HEXAGONS 50x43,3 CM
- MT-1 : STAINLESS STEEL HAIRLINE H 80 MM
MT-2 : POWDER COATING METAL, BLACK, DOFF
MT-3 : POWDER COATING METAL, WHITE, DOFF
- PT-1 : PAINT, DULUX XXX
- SP-1 : SPRAY PAINT (DUCO) YELLOW
SP-2 : SPRAY PAINT (DUCO) BLUE
SP-3 : SPRAY PAINT (DUCO) TOSCA
- FB-1 : FABRIC, ATEJA LORENZIA, FESTUS 160
FB-2 : FABRIC, ATEJA LORENZIA, COLOR MATCH TO LM-4
FB-3 : FABRIC, VANIA, FORTE
- GL-1 : CLEAR GLASS
- BG-1 : BACKPAINTED GLASS, HIMALAYA ABADI - GLASSTONE - SUPER WHITE
- LM-1 : HPL, AICA AS-14062CS83 LIGHTGRAY LEGER STONE
LM-2 : HPL, CARTA CT 7878 T ARGENTINA CHERRY
LM-3 : HPL, TACO TH 006 AA MIDNIGHT GREY
LM-4 : HPL, TACO TH 021 AA CANARY YELLOW
- SF-1 : STICKER PRINTING, DOFF
SF-2 : ACRYLIC LASER CU FIN. IN SPRAY PAINT, DOFF
SF-3 : GRADATION STICKER ONE SIDE - WHITE
SF-4 : STICKER FILM GREY 40%

Bintaro Business Centre Building
Jl. RC Veteran No. 1-1 Bintaro
Phone: +62 21 7357679
Fax: +62 21 7433946
www.dezanstudio.com
admin@dezanstudio.com

CLIENT

UNDP

PROJECT

2019 - UNDP PROJECT 3A

DRAWING TITLE


C-5 PRINTING CABINET

DRAWING No.	REVISION
INT-125	REV A
SCALE 1:20 @A3	CHECKED AS
DATE November 5, 2020	DRAWN AS



03 TOP VIEW

Scale: 1:20

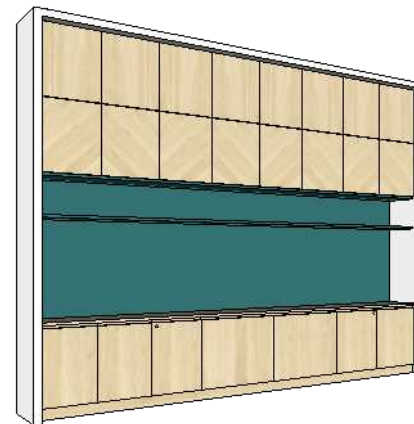


02 C-6 HANGING CABINET

Scale: NTS




01 KEYPLAN

Scale: 1:200

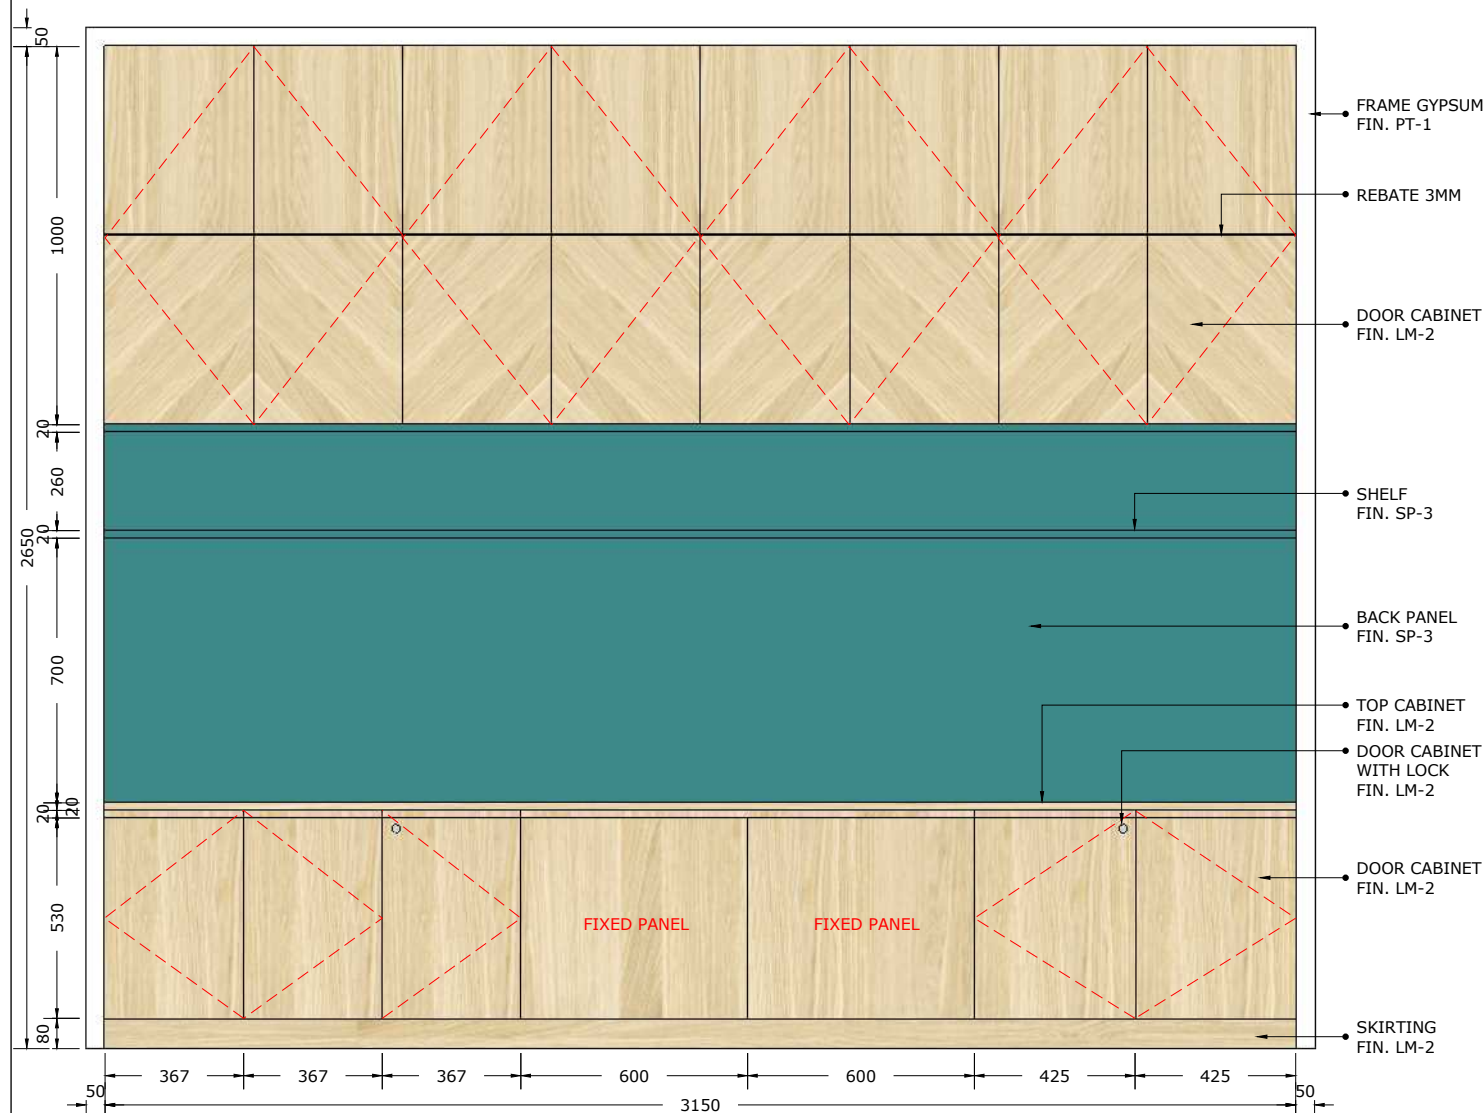


04 FRONT VIEW

Scale: 1:20

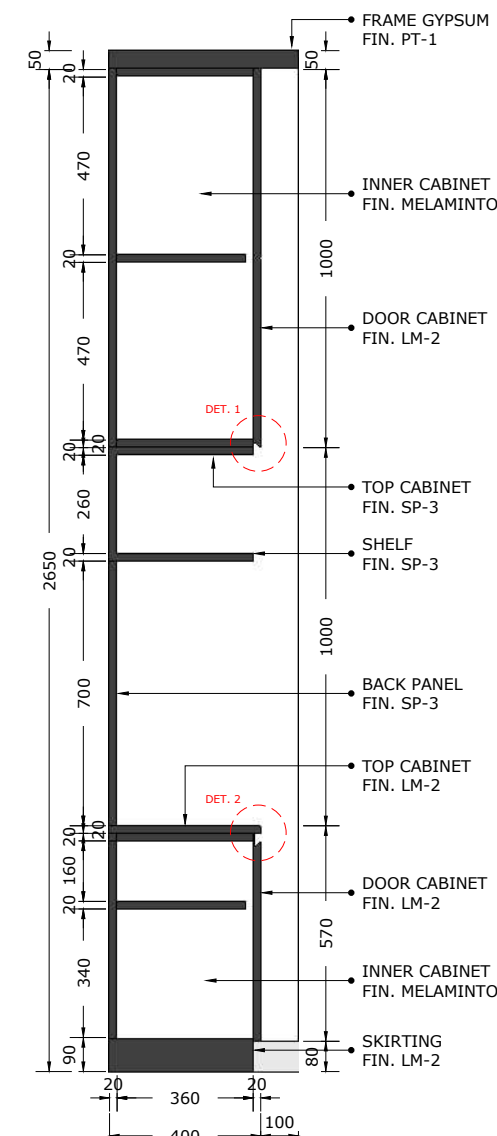


05 SECTION B

Scale: 1:20

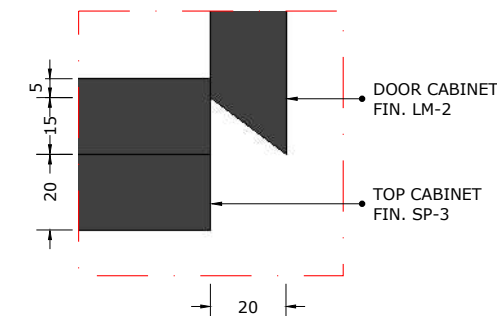

06 DETAIL 1

Scale: 1:2

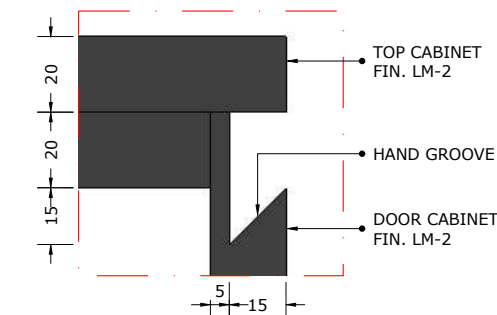

07 DETAIL 2

Scale: 1:2

- NOTE :
- SPC-1 : SPC FLOOR, PATINA, LEMON
SPC-2 : PATINA, SKIRTING 80
- CP-1 : SMJ CARPET, BLUESTONE, TIMELESS GREY 50 X 50 CM
CP-2 : SMJ CARPET, CONCEPT LOOP, BLUE SCREEN 50 X 50 CM
CP-3 : SMJ CARPET, COLOR BOX, YELLOW LEMON 50 X 50 CM
CP-4 : VOXFLO, PRISM 01, HEXAGONS 50x43,3 CM
CP-5 : VOXFLO, PRISM 33, HEXAGONS 50x43,3 CM
CP-6 : VOXFLO, CRYSTAL 04 HEXAGONS 50x43,3 CM
CP-7 : VOXFLO, CRYSTAL 10 HEXAGONS 50x43,3 CM
- MT-1 : STAINLESS STEEL HAIRLINE H 80 MM
MT-2 : POWDER COATING METAL, BLACK, DOFF
MT-3 : POWDER COATING METAL, WHITE, DOFF
- PT-1 : PAINT, DULUX XXX
- SP-1 : SPRAY PAINT (DUCO) YELLOW
SP-2 : SPRAY PAINT (DUCO) BLUE
SP-3 : SPRAY PAINT (DUCO) TOSCA
- FB-1 : FABRIC, ATEJA LORENZIA, FESTUS 160
FB-2 : FABRIC, ATEJA LORENZIA, COLOR MATCH TO LM-4
FB-3 : FABRIC, VANIA, FORTE
- GL-1 : CLEAR GLASS
- BG-1 : BACKPAINTED GLASS, HIMALAYA ABADI - GLASSTONE - SUPER WHITE
- LM-1 : HPL, AICA AS-14062CS83 LIGHTGRAY LEGER STONE
LM-2 : HPL, CARTA CT 7878 T ARGENTINA CHERRY
LM-3 : HPL, TACO TH 006 AA MIDNIGHT GREY
LM-4 : HPL, TACO TH 021 AA CANARY YELLOW
- SF-1 : STICKER PRINTING, DOFF
SF-2 : ACRYLIC LASER CU FIN. IN SPRAY PAINT, DOFF
SF-3 : GRADATION STICKER ONE SIDE - WHITE
SF-4 : STICKER FILM GREY 40%

Bintaro Business Centre Building
Jl. RC Veteran No. 1-1 Bintaro
Phone: +62 21 7357679
Fax: +62 21 7433946
www.dezanstudio.com
admin@dezanstudio.com

CLIENT

UNDP





PROJECT

2019 - UNDP PROJECT 3A

DRAWING TITLE

C-6 HANGING CABINET

DRAWING No.	REVISION
INT-126	REV A
SCALE	1:20 @A3
DATE	November 5, 2020
CHECKED	AS
DRAWN	AS

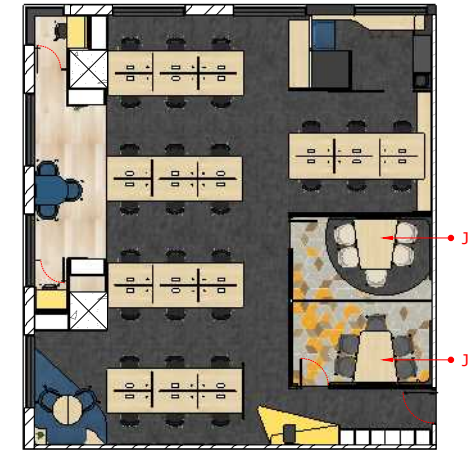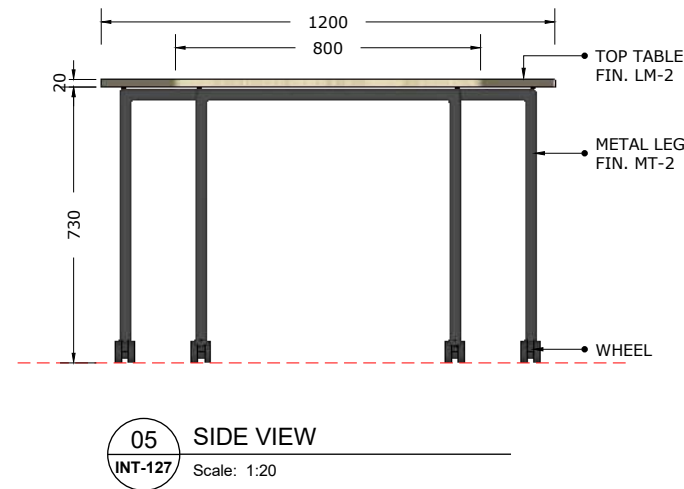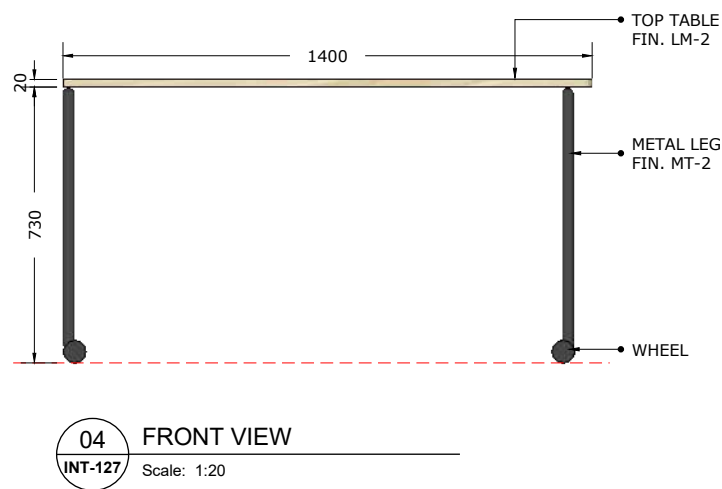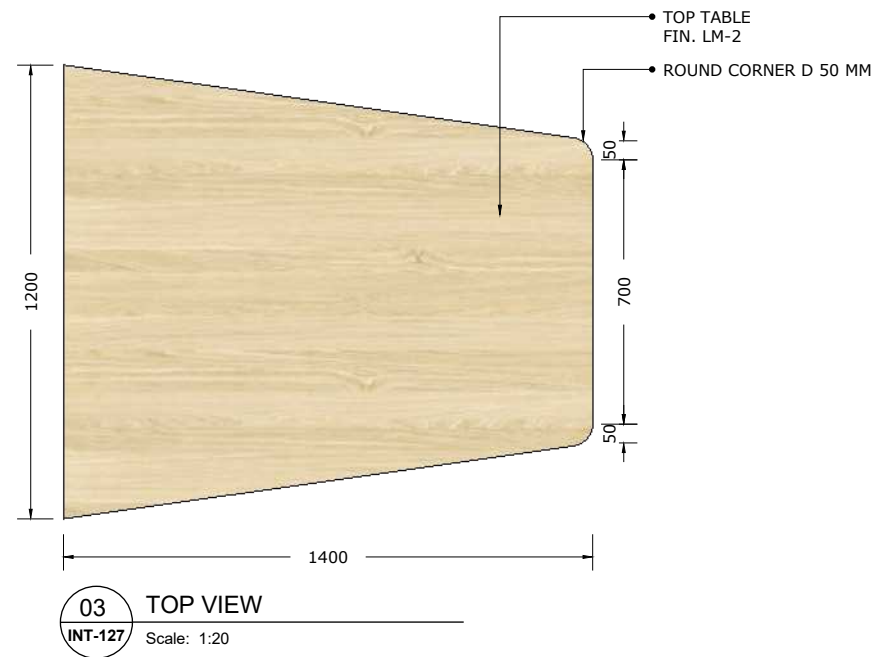


01 KEYPLAN
INT-127 Scale: 1:200


- NOTE :
- SPC-1 : SPC FLOOR, PATINA, LEMON
SPC-2 : PATINA, SKIRTING 80
- CP-1 : SMJ CARPET, BLUESTONE, TIMELESS GREY 50 X 50 CM
CP-2 : SMJ CARPET, CONCEPT LOOP, BLUE SCREEN 50 X 50 CM
CP-3 : SMJ CARPET, COLOR BOX, YELLOW LEMON 50 X 50 CM
CP-4 : VOXFLO, PRISM 01, HEXAGONS 50x43,3 CM
CP-5 : VOXFLO, PRISM 33, HEXAGONS 50x43,3 CM
CP-6 : VOXFLO, CRYSTAL 04 HEXAGONS 50x43,3 CM
CP-7 : VOXFLO, CRYSTAL 10 HEXAGONS 50x43,3 CM
- MT-1 : STAINLESS STEEL HAIRLINE H 80 MM
MT-2 : POWDER COATING METAL, BLACK, DOFF
MT-3 : POWDER COATING METAL, WHITE, DOFF
- PT-1 : PAINT, DULUX XXX
- SP-1 : SPRAY PAINT (DUCO) YELLOW
SP-2 : SPRAY PAINT (DUCO) BLUE
SP-3 : SPRAY PAINT (DUCO) TOSCA
- FB-1 : FABRIC, ATEJA LORENZIA, FESTUS 160
FB-2 : FABRIC, ATEJA LORENZIA, COLOR MATCH TO LM-4
FB-3 : FABRIC, VANIA, FORTE
- GL-1 : CLEAR GLASS
- BG-1 : BACKPAINTED GLASS, HIMALAYA ABADI - GLASSTONE - SUPER WHITE
- LM-1 : HPL, AICA AS-14062CS83 LIGHTGRAY LEGER STONE
LM-2 : HPL, CARTA CT 7878 T ARGENTINA CHERRY
LM-3 : HPL, TACO TH 006 AA MIDNIGHT GREY
LM-4 : HPL, TACO TH 021 AA CANARY YELLOW
- SF-1 : STICKER PRINTING, DOFF
SF-2 : ACRYLIC LASER CU FIN. IN SPRAY PAINT, DOFF
SF-3 : GRADATION STICKER ONE SIDE - WHITE
SF-4 : STICKER FILM GREY 40%

Bintaro Business Centre Building
Jl. RC Veteran No. 1-1 Bintaro
Phone: +62 21 7357679
Fax: +62 21 7433946
www.dezanstudio.com
admin@dezanstudio.com


CLIENT	
UNDP	
PROJECT	
2019 - UNDP PROJECT 3A	
DRAWING TITLE	
J-1 MEETING TABLE	
DRAWING No.	REVISION
INT-127	REV A
SCALE	1:20 @A3
DATE	November 5, 2020
CHECKED	AS
DRAWN	AS

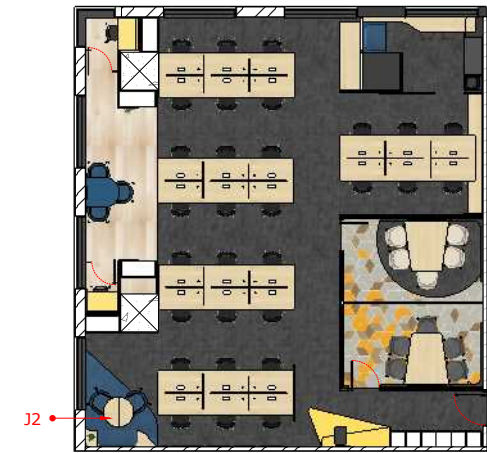


01 KEYPLAN
INT-128 Scale: 1:200

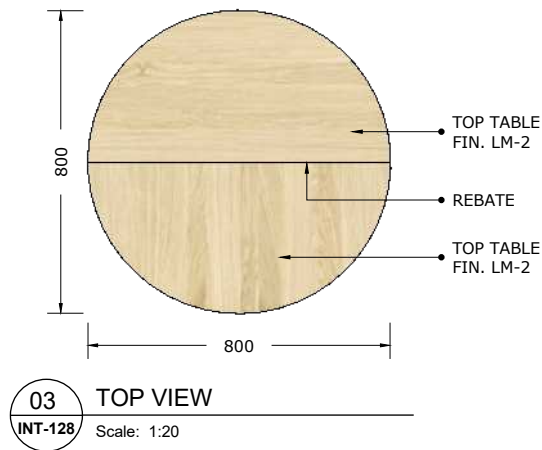


03 TOP VIEW
INT-128 Scale: 1:20

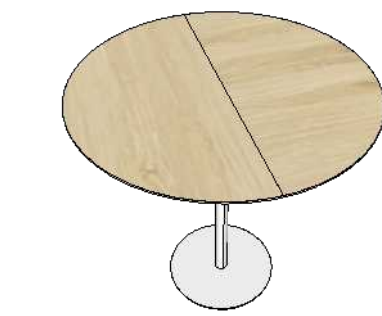


02 J-2 DISCUSSION TABLE 1
INT-128 Scale: NTS

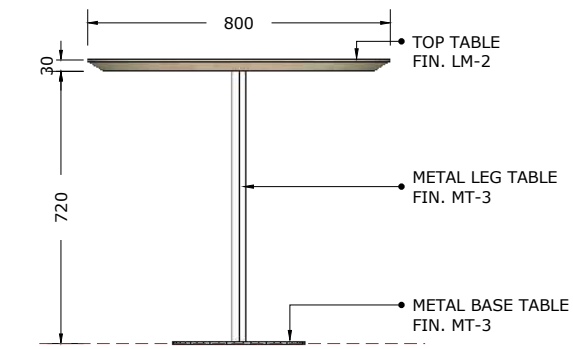

04 FRONT VIEW
INT-128 Scale: 1:20

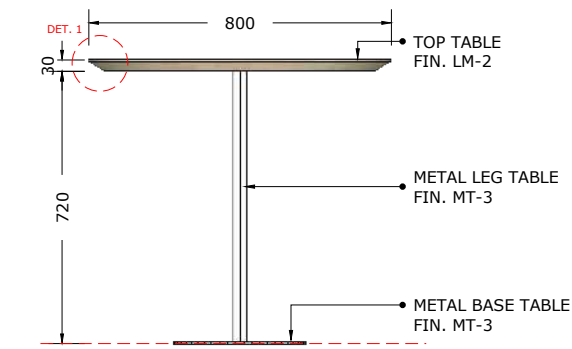

05 SIDE VIEW
INT-128 Scale: 1:20

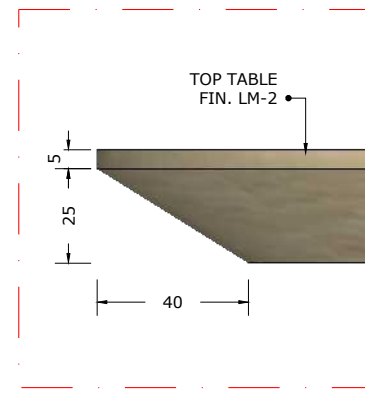

05 DETAIL 1
INT-128 Scale: 1:2

- NOTE :
- SPC-1 : SPC FLOOR, PATINA, LEMON
SPC-2 : PATINA, SKIRTING 80
- CP-1 : SMJ CARPET, BLUESTONE, TIMELESS GREY 50 X 50 CM
CP-2 : SMJ CARPET, CONCEPT LOOP, BLUE SCREEN 50 X 50 CM
CP-3 : SMJ CARPET, COLOR BOX, YELLOW LEMON 50 X 50 CM
CP-4 : VOXFLO, PRISM 01, HEXAGONS 50x43,3 CM
CP-5 : VOXFLO, PRISM 33, HEXAGONS 50x43,3 CM
CP-6 : VOXFLO, CRYSTAL 04 HEXAGONS 50x43,3 CM
CP-7 : VOXFLO, CRYSTAL 10 HEXAGONS 50x43,3 CM
- MT-1 : STAINLESS STEEL HAIRLINE H 80 MM
MT-2 : POWDER COATING METAL, BLACK, DOFF
MT-3 : POWDER COATING METAL, WHITE, DOFF
- PT-1 : PAINT, DULUX XXX
- SP-1 : SPRAY PAINT (DUCO) YELLOW
SP-2 : SPRAY PAINT (DUCO) BLUE
SP-3 : SPRAY PAINT (DUCO) TOSCA
- FB-1 : FABRIC, ATEJA LORENZIA, FESTUS 160
FB-2 : FABRIC, ATEJA LORENZIA, COLOR MATCH TO LM-4
FB-3 : FABRIC, VANIA, FORTE
- GL-1 : CLEAR GLASS
- BG-1 : BACKPAINTED GLASS, HIMALAYA ABADI - GLASSTONE - SUPER WHITE
- LM-1 : HPL, AICA AS-14062CS83 LIGHTGRAY LEGER STONE
LM-2 : HPL, CARTA CT 7878 T ARGENTINA CHERRY
LM-3 : HPL, TACO TH 006 AA MIDNIGHT GREY
LM-4 : HPL, TACO TH 021 AA CANARY YELLOW
- SF-1 : STICKER PRINTING, DOFF
SF-2 : ACRYLIC LASER CU FIN. IN SPRAY PAINT, DOFF
SF-3 : GRADATION STICKER ONE SIDE - WHITE
SF-4 : STICKER FILM GREY 40%

Bintaro Business Centre Building
Jl. RC Veteran No. 1-1 Bintaro
Phone: +62 21 7357679
Fax: +62 21 7433946
www.dezanstudio.com
admin@dezanstudio.com

CLIENT

UNDP


PROJECT

2019 - UNDP PROJECT 3A


DRAWING TITLE

J-2 DISCUSSION TABLE 1


DRAWING No.	REVISION
INT-128	REV A
SCALE 1:20 @A3	CHECKED AS
DATE November 5, 2020	DRAWN AS

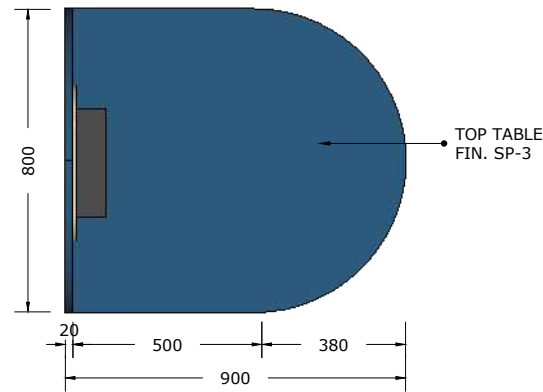


03 TOP VIEW
INT-129 Scale: 1:20

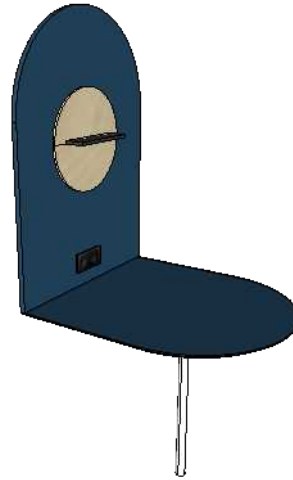


02 J-3 DISCUSSION TABLE 2
INT-129 Scale: NTS

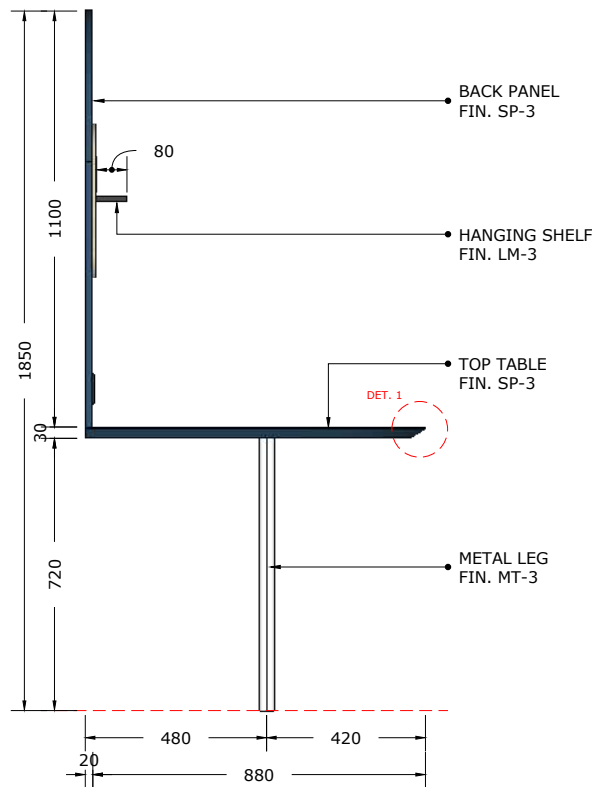


04 FRONT VIEW
INT-129 Scale: 1:20

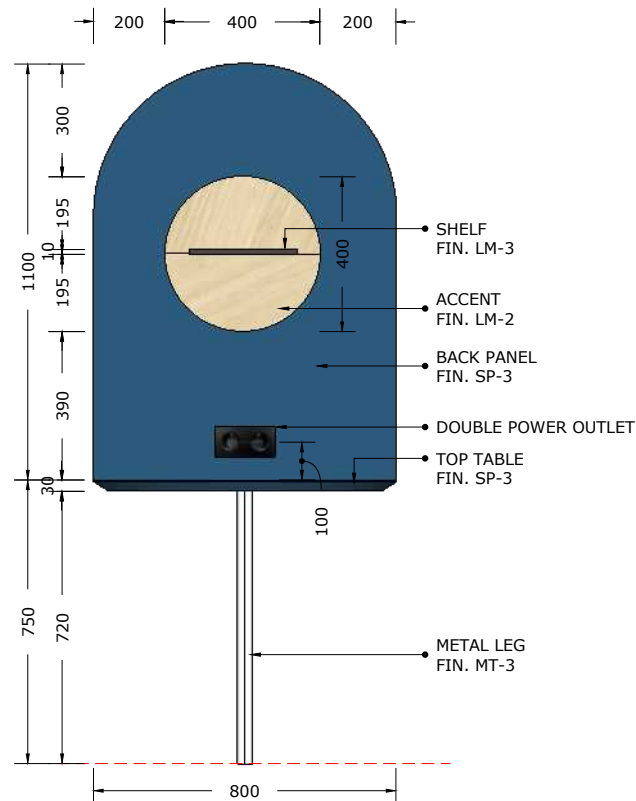

05 SIDE VIEW
INT-129 Scale: 1:20

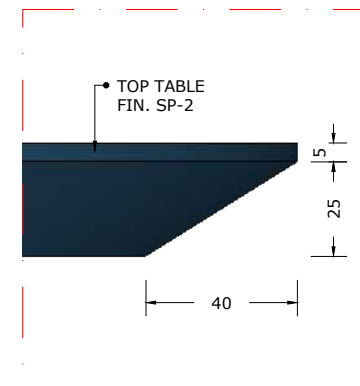

05 DETAIL 1
INT-129 Scale: 1:2

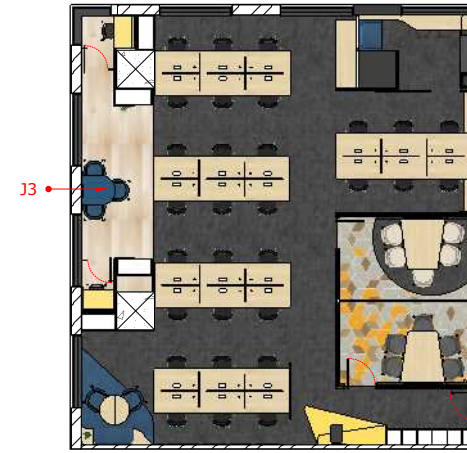

01 KEYPLAN
INT-129 Scale: 1:200

- NOTE :
- SPC-1 : SPC FLOOR, PATINA, LEMON
SPC-2 : PATINA, SKIRTING 80
- CP-1 : SMJ CARPET, BLUESTONE, TIMELESS GREY 50 X 50 CM
CP-2 : SMJ CARPET, CONCEPT LOOP, BLUE SCREEN 50 X 50 CM
CP-3 : SMJ CARPET, COLOR BOX, YELLOW LEMON 50 X 50 CM
CP-4 : VOXFLO, PRISM 01, HEXAGONS 50x43,3 CM
CP-5 : VOXFLO, PRISM 33, HEXAGONS 50x43,3 CM
CP-6 : VOXFLO, CRYSTAL 04 HEXAGONS 50x43,3 CM
CP-7 : VOXFLO, CRYSTAL 10 HEXAGONS 50x43,3 CM
- MT-1 : STAINLESS STEEL HAIRLINE H 80 MM
MT-2 : POWDER COATING METAL, BLACK, DOFF
MT-3 : POWDER COATING METAL, WHITE, DOFF
- PT-1 : PAINT, DULUX XXX
- SP-1 : SPRAY PAINT (DUCO) YELLOW
SP-2 : SPRAY PAINT (DUCO) BLUE
SP-3 : SPRAY PAINT (DUCO) TOSCA
- FB-1 : FABRIC, ATEJA LORENZIA, FESTUS 160
FB-2 : FABRIC, ATEJA LORENZIA, COLOR MATCH TO LM-4
FB-3 : FABRIC, VANIA, FORTE
- GL-1 : CLEAR GLASS
- BG-1 : BACKPAINTED GLASS, HIMALAYA ABADI - GLASSTONE - SUPER WHITE
- LM-1 : HPL, AICA AS-14062CS83 LIGHTGRAY LEGER STONE
LM-2 : HPL, CARTA CT 7878 T ARGENTINA CHERRY
LM-3 : HPL, TACO TH 006 AA MIDNIGHT GREY
LM-4 : HPL, TACO TH 021 AA CANARY YELLOW
- SF-1 : STICKER PRINTING, DOFF
SF-2 : ACRYLIC LASER CU FIN. IN SPRAY PAINT, DOFF
SF-3 : GRADATION STICKER ONE SIDE - WHITE
SF-4 : STICKER FILM GREY 40%

Bintaro Business Centre Building
Jl. RC Veteran No. 1-1 Bintaro
Phone: +62 21 7357679
Fax: +62 21 7433946
www.dezanstudio.com
admin@dezanstudio.com

CLIENT

UNDP


PROJECT

2019 - UNDP PROJECT 3A


DRAWING TITLE

J-3 DISCUSSION TABLE 2


DRAWING No.	REVISION
INT-129	REV A
SCALE 1:20 @A3	CHECKED AS
DATE November 5, 2020	DRAWN AS

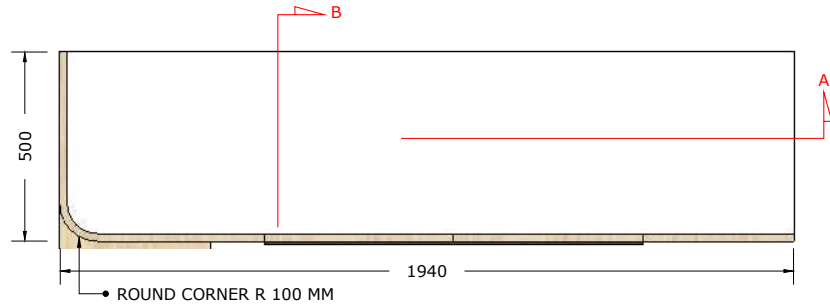


03 TOP VIEW
INT-130 Scale: 1:20

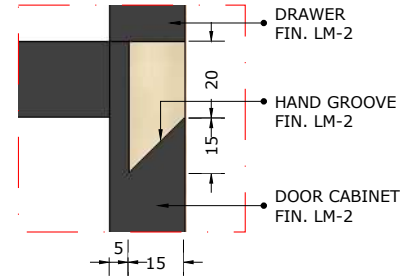


08 DETAIL 2
INT-130 Scale: 1:2

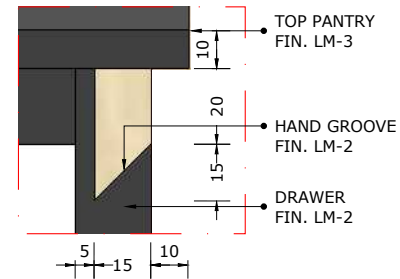


09 DETAIL 3
INT-130 Scale: 1:2

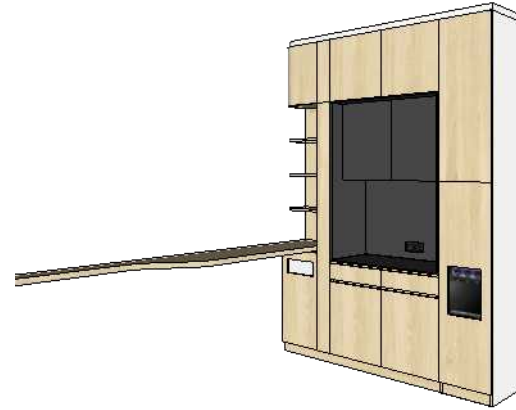


02 J-4 PANTRY CABINET
INT-130 Scale: NTS

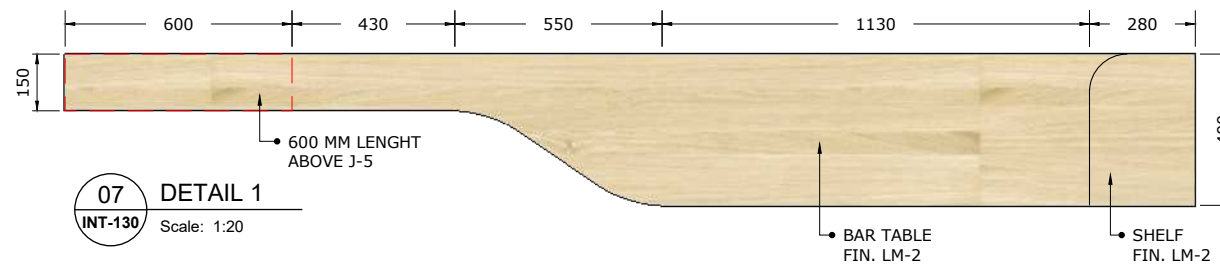


07 DETAIL 1
INT-130 Scale: 1:20

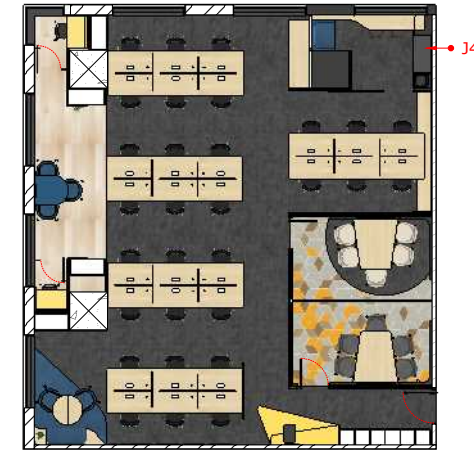


01 KEYPLAN
INT-130 Scale: 1:200

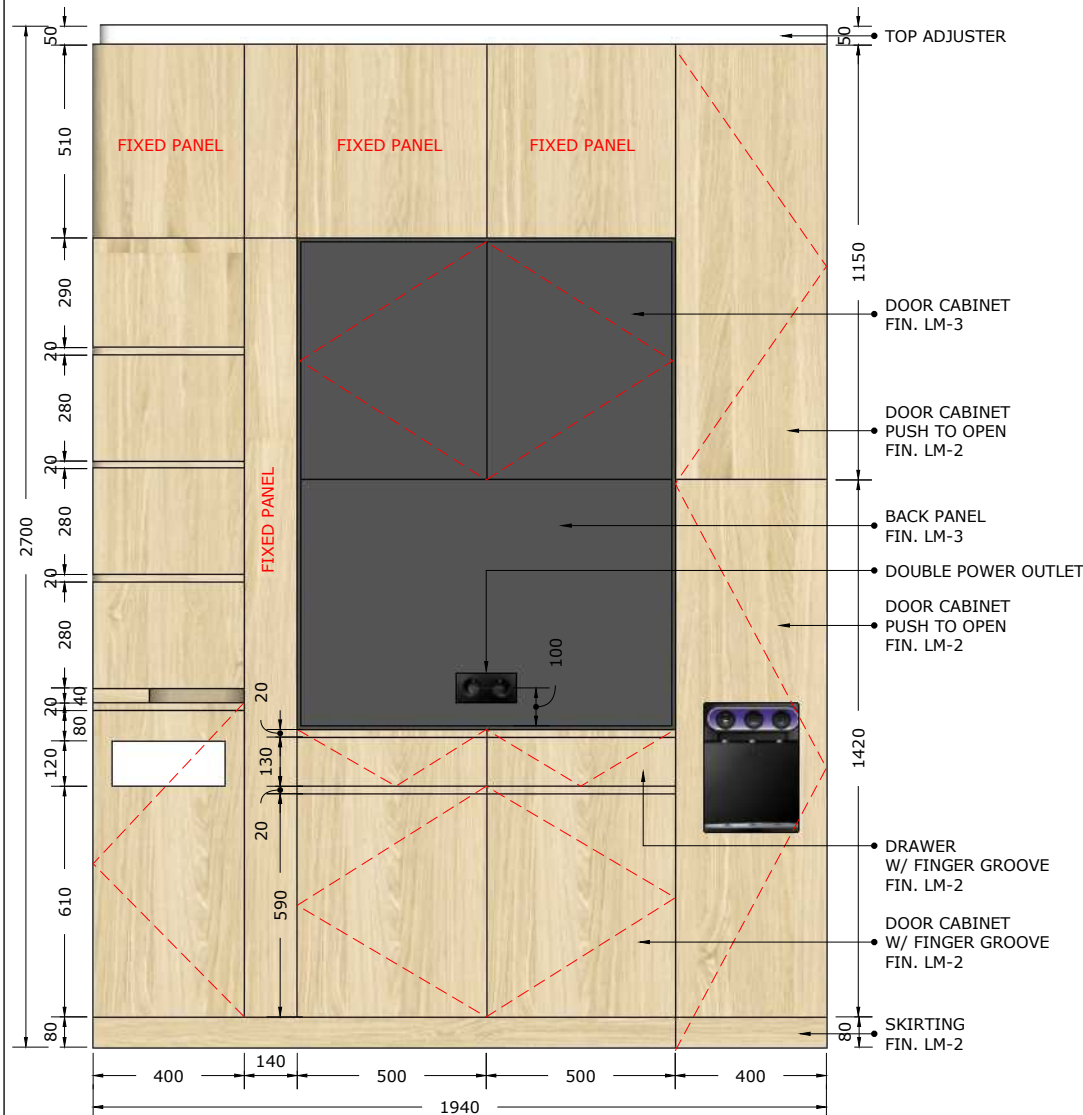

04 FRONT VIEW
INT-130 Scale: 1:20

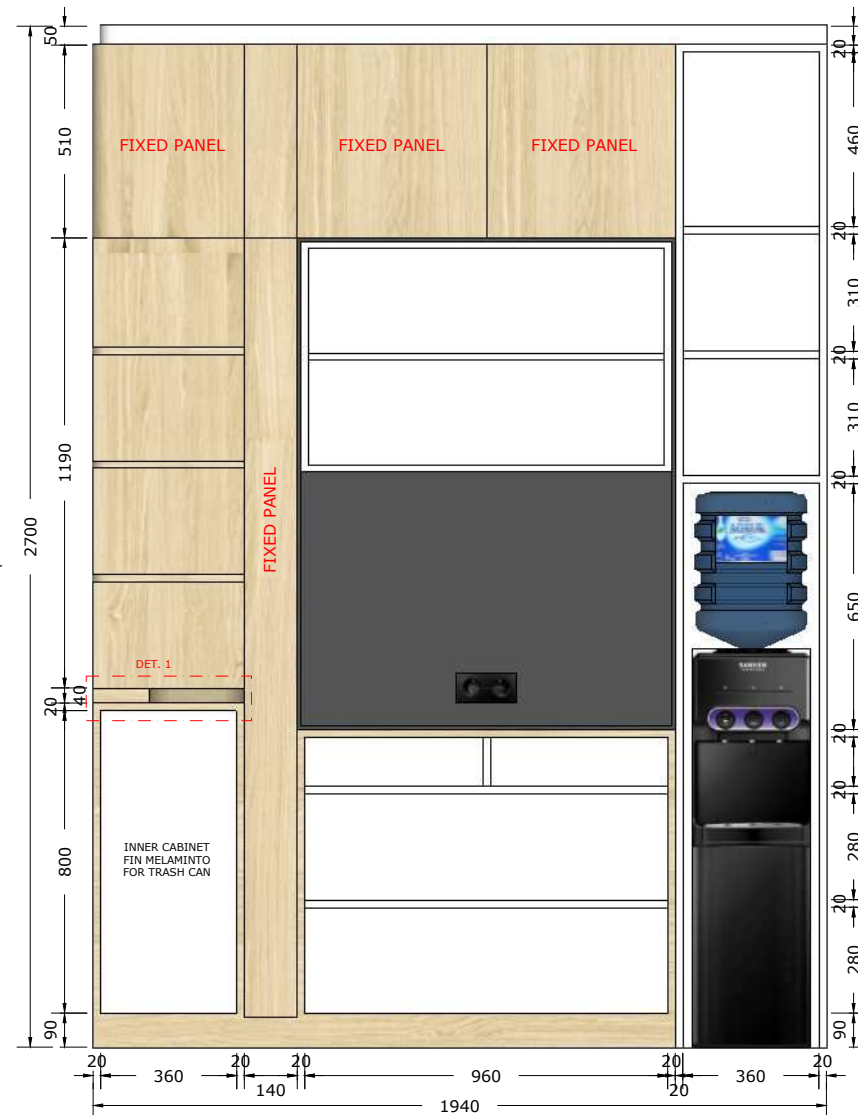

05 SECTION A
INT-130 Scale: 1:20

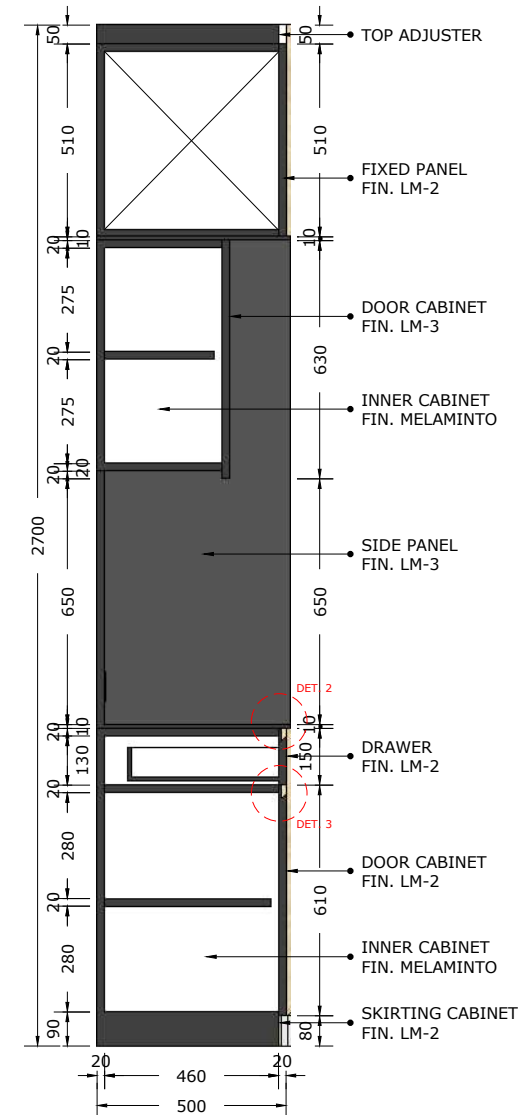

06 SECTION B
INT-130 Scale: 1:20

- NOTE:
- SPC-1 : SPC FLOOR, PATINA, LEMON
SPC-2 : PATINA, SKIRTING 80
- CP-1 : SMJ CARPET, BLUESTONE, TIMELESS GREY 50 X 50 CM
CP-2 : SMJ CARPET, CONCEPT LOOP, BLUE SCREEN 50 X 50 CM
CP-3 : SMJ CARPET, COLOR BOX, YELLOW LEMON 50 X 50 CM
CP-4 : VOXFLO, PRISM 01, HEXAGONS 50x43,3 CM
CP-5 : VOXFLO, PRISM 33, HEXAGONS 50x43,3 CM
CP-6 : VOXFLO, CRYSTAL 04 HEXAGONS 50x43,3 CM
CP-7 : VOXFLO, CRYSTAL 10 HEXAGONS 50x43,3 CM
- MT-1 : STAINLESS STEEL HAIRLINE H 80 MM
MT-2 : POWDER COATING METAL, BLACK, DOFF
MT-3 : POWDER COATING METAL, WHITE, DOFF
- PT-1 : PAINT, DULUX XXX
- SP-1 : SPRAY PAINT (DUCCO) YELLOW
SP-2 : SPRAY PAINT (DUCCO) BLUE
SP-3 : SPRAY PAINT (DUCCO) TOSCA
- FB-1 : FABRIC, ATEJA LORENZIA, FESTUS 160
FB-2 : FABRIC, ATEJA LORENZIA, COLOR MATCH TO LM-4
FB-3 : FABRIC, VANIA, FORTE
- GL-1 : CLEAR GLASS
- BG-1 : BACKPAINTED GLASS, HIMALAYA ABADI - GLASSTONE - SUPER WHITE
- LM-1 : HPL, AICA AS-14062CS83 LIGHTGRAY LEGER STONE
LM-2 : HPL, CARTA CT 7878 T ARGENTINA CHERRY
LM-3 : HPL, TACO TH 006 AA MIDNIGHT GREY
LM-4 : HPL, TACO TH 021 AA CANARY YELLOW
- SF-1 : STICKER PRINTING, DOFF
SF-2 : ACRYLIC LASER CU FIN. IN SPRAY PAINT, DOFF
SF-3 : GRADATION STICKER ONE SIDE - WHITE
SF-4 : STICKER FILM GREY 40%

Bintaro Business Centre Building
Jl. RC Veteran No. 1-1 Bintaro
Phone: +62 21 7357679
Fax: +62 21 7433946
www.dezanstudio.com
admin@dezanstudio.com

CLIENT

UNDP


PROJECT

2019 - UNDP PROJECT 3A


DRAWING TITLE

J-4 PANTRY CABINET


DRAWING No.	REVISION
INT-130	REV A
SCALE 1:20 @A3	CHECKED AS
DATE November 5, 2020	DRAWN AS

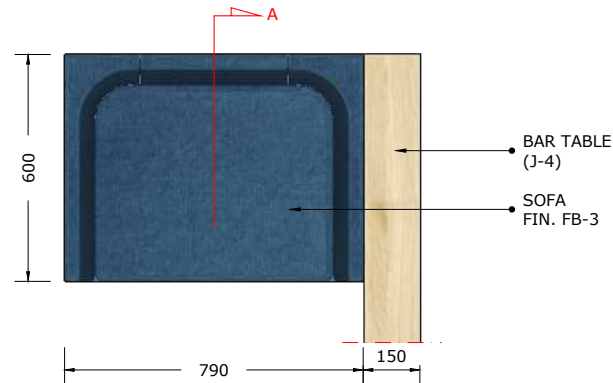

03 TOP VIEW
INT-131 Scale: 1:20

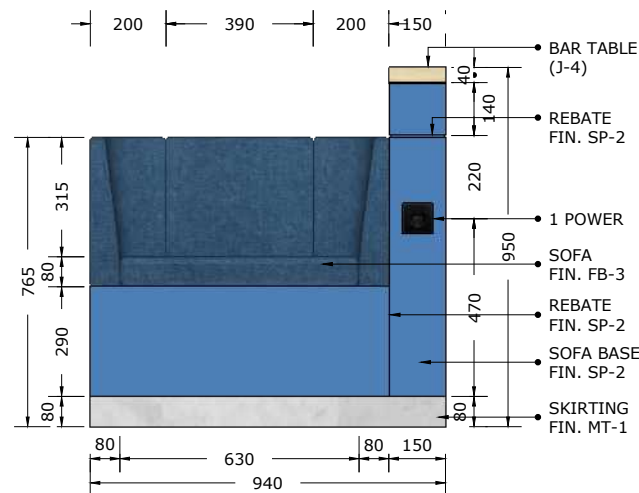


04 FRONT VIEW
INT-131 Scale: 1:20

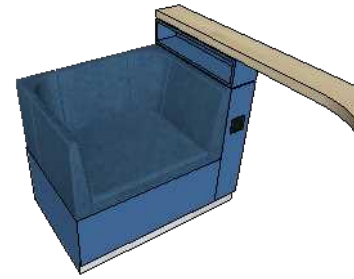

02 J-5 SOFA 1 SEATER
INT-131 Scale: NTS



01 KEYPLAN
INT-131 Scale: 1:200

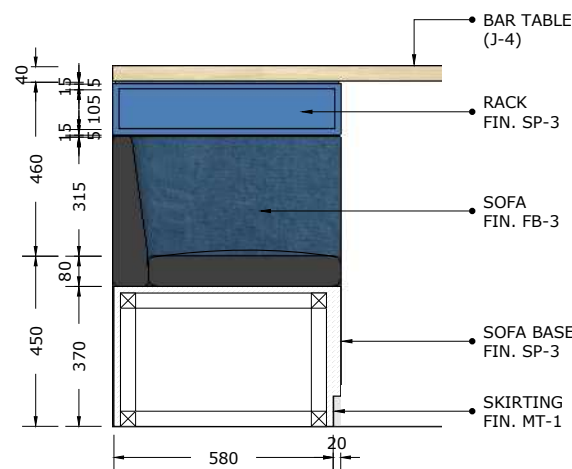

05 SECTION A
INT-131 Scale: 1:20

- NOTE :
- SPC-1 : SPC FLOOR, PATINA, LEMON
SPC-2 : PATINA, SKIRTING 80
- CP-1 : SMJ CARPET, BLUESTONE, TIMELESS GREY 50 X 50 CM
CP-2 : SMJ CARPET, CONCEPT LOOP, BLUE SCREEN 50 X 50 CM
CP-3 : SMJ CARPET, COLOR BOX, YELLOW LEMON 50 X 50 CM
CP-4 : VOXFLO, PRISM 01, HEXAGONS 50x43,3 CM
CP-5 : VOXFLO, PRISM 33, HEXAGONS 50x43,3 CM
CP-6 : VOXFLO, CRYSTAL 04 HEXAGONS 50x43,3 CM
CP-7 : VOXFLO, CRYSTAL 10 HEXAGONS 50x43,3 CM
- MT-1 : STAINLESS STEEL HAIRLINE H 80 MM
MT-2 : POWDER COATING METAL, BLACK, DOFF
MT-3 : POWDER COATING METAL, WHITE, DOFF
- PT-1 : PAINT, DULUX XXX
- SP-1 : SPRAY PAINT (DUCO) YELLOW
SP-2 : SPRAY PAINT (DUCO) BLUE
SP-3 : SPRAY PAINT (DUCO) TOSCA
- FB-1 : FABRIC, ATEJA LORENZIA, FESTUS 160
FB-2 : FABRIC, ATEJA LORENZIA, COLOR MATCH TO LM-4
FB-3 : FABRIC, VANIA, FORTE
- GL-1 : CLEAR GLASS
- BG-1 : BACKPAINTED GLASS, HIMALAYA ABADI - GLASSTONE - SUPER WHITE
- LM-1 : HPL, AICA AS-14062CS83 LIGHTGRAY LEGER STONE
LM-2 : HPL, CARTA CT 7878 T ARGENTINA CHERRY
LM-3 : HPL, TACO TH 006 AA MIDNIGHT GREY
LM-4 : HPL, TACO TH 021 AA CANARY YELLOW
- SF-1 : STICKER PRINTING, DOFF
SF-2 : ACRYLIC LASER CU FIN. IN SPRAY PAINT, DOFF
SF-3 : GRADATION STICKER ONE SIDE - WHITE
SF-4 : STICKER FILM GREY 40%

Bintaro Business Centre Building
Jl. RC Veteran No. 1-1 Bintaro
Phone: +62 21 7357679
Fax: +62 21 7433946
www.dezanstudio.com
admin@dezanstudio.com

CLIENT

UNDP

PROJECT

2019 - UNDP PROJECT 3A

DRAWING TITLE

J-5 SOFA 1 SEATER


DRAWING No.	REVISION
INT-131	REV A
SCALE 1:20 @A3	CHECKED AS
DATE November 5, 2020	DRAWN AS




02 J-6 SOFA BENCH
Scale: NTS




01 KEYPLAN
Scale: 1:200

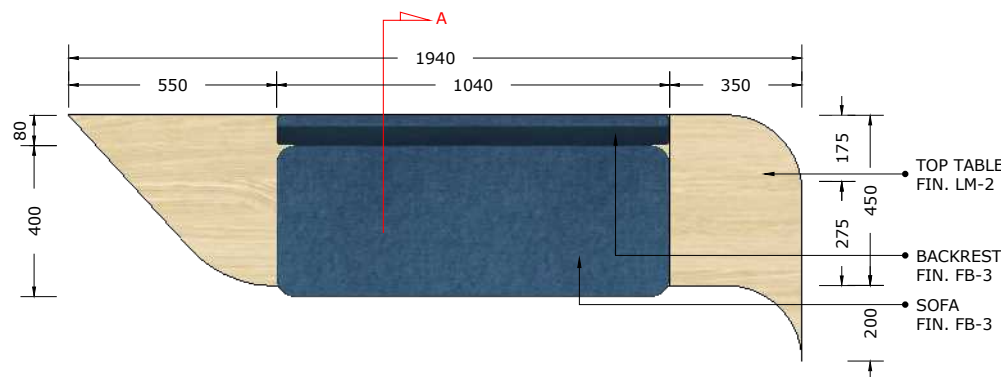

03 TOP VIEW
Scale: 1:20

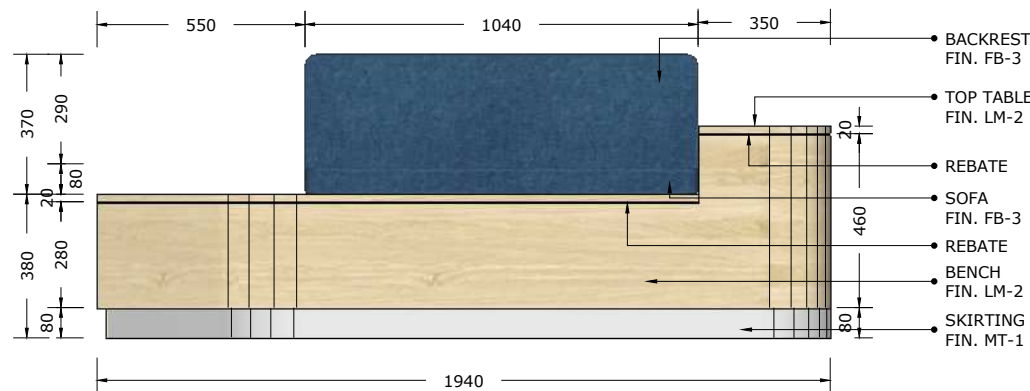

04 FRONT VIEW
Scale: 1:20

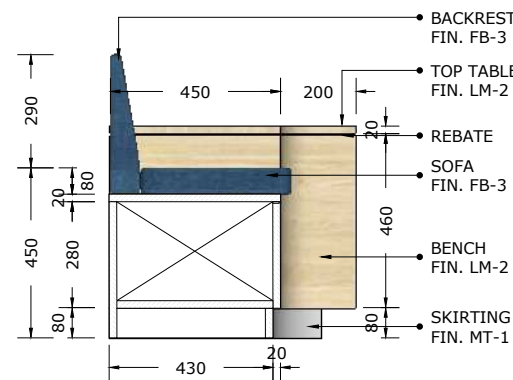


05 SECTION A
Scale: 1:20


- NOTE :
- SPC-1 : SPC FLOOR, PATINA, LEMON
SPC-2 : PATINA, SKIRTING 80
- CP-1 : SMJ CARPET, BLUESTONE, TIMELESS GREY 50 X 50 CM
CP-2 : SMJ CARPET, CONCEPT LOOP, BLUE SCREEN 50 X 50 CM
CP-3 : SMJ CARPET, COLOR BOX, YELLOW LEMON 50 X 50 CM
CP-4 : VOXFLO, PRISM 01, HEXAGONS 50x43,3 CM
CP-5 : VOXFLO, PRISM 33, HEXAGONS 50x43,3 CM
CP-6 : VOXFLO, CRYSTAL 04 HEXAGONS 50x43,3 CM
CP-7 : VOXFLO, CRYSTAL 10 HEXAGONS 50x43,3 CM
- MT-1 : STAINLESS STEEL HAIRLINE H 80 MM
MT-2 : POWDER COATING METAL, BLACK, DOFF
MT-3 : POWDER COATING METAL, WHITE, DOFF
- PT-1 : PAINT, DULUX XXX
- SP-1 : SPRAY PAINT (DUCO) YELLOW
SP-2 : SPRAY PAINT (DUCO) BLUE
SP-3 : SPRAY PAINT (DUCO) TOSCA
- FB-1 : FABRIC, ATEJA LORENZIA, FESTUS 160
FB-2 : FABRIC, ATEJA LORENZIA, COLOR MATCH TO LM-4
FB-3 : FABRIC, VANIA, FORTE
- GL-1 : CLEAR GLASS
- BG-1 : BACKPAINTED GLASS, HIMALAYA ABADI - GLASSTONE - SUPER WHITE
- LM-1 : HPL, AICA AS-14062CS83 LIGHTGRAY LEGER STONE
LM-2 : HPL, CARTA CT 7878 T ARGENTINA CHERRY
LM-3 : HPL, TACO TH 006 AA MIDNIGHT GREY
LM-4 : HPL, TACO TH 021 AA CANARY YELLOW
- SF-1 : STICKER PRINTING, DOFF
SF-2 : ACRYLIC LASER CU FIN. IN SPRAY PAINT, DOFF
SF-3 : GRADATION STICKER ONE SIDE - WHITE
SF-4 : STICKER FILM GREY 40%

Bintaro Business Centre Building
Jl. RC Veteran No. 1-1 Bintaro
Phone: +62 21 7357679
Fax: +62 21 7433946
www.dezanstudio.com
admin@dezanstudio.com


CLIENT	
UNDP	
PROJECT	
2019 - UNDP PROJECT 3A	
DRAWING TITLE	
J-6 SOFA BENCH	
DRAWING No.	REVISION
INT-132	REV A
SCALE	1:20 @A3
DATE	November 5, 2020
CHECKED	AS
DRAWN	AS

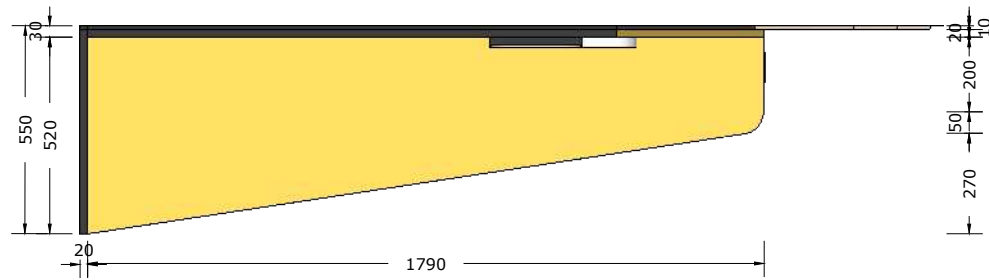


03 TOP VIEW
INT-133 Scale: 1:20

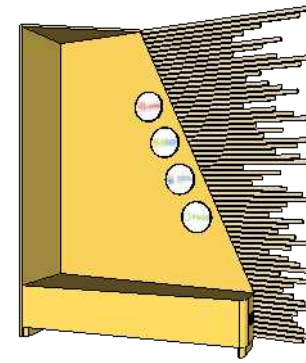


02 J-7 BENCH
INT-133 Scale: NTS

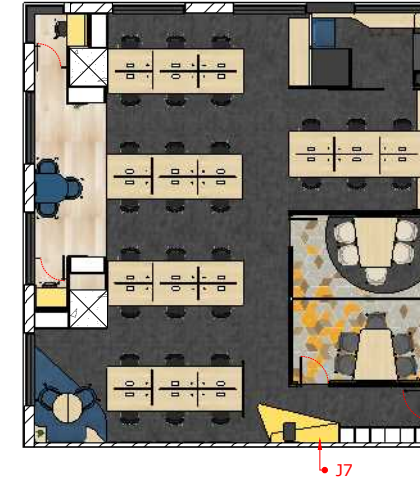

01 KEYPLAN
INT-133 Scale: 1:200

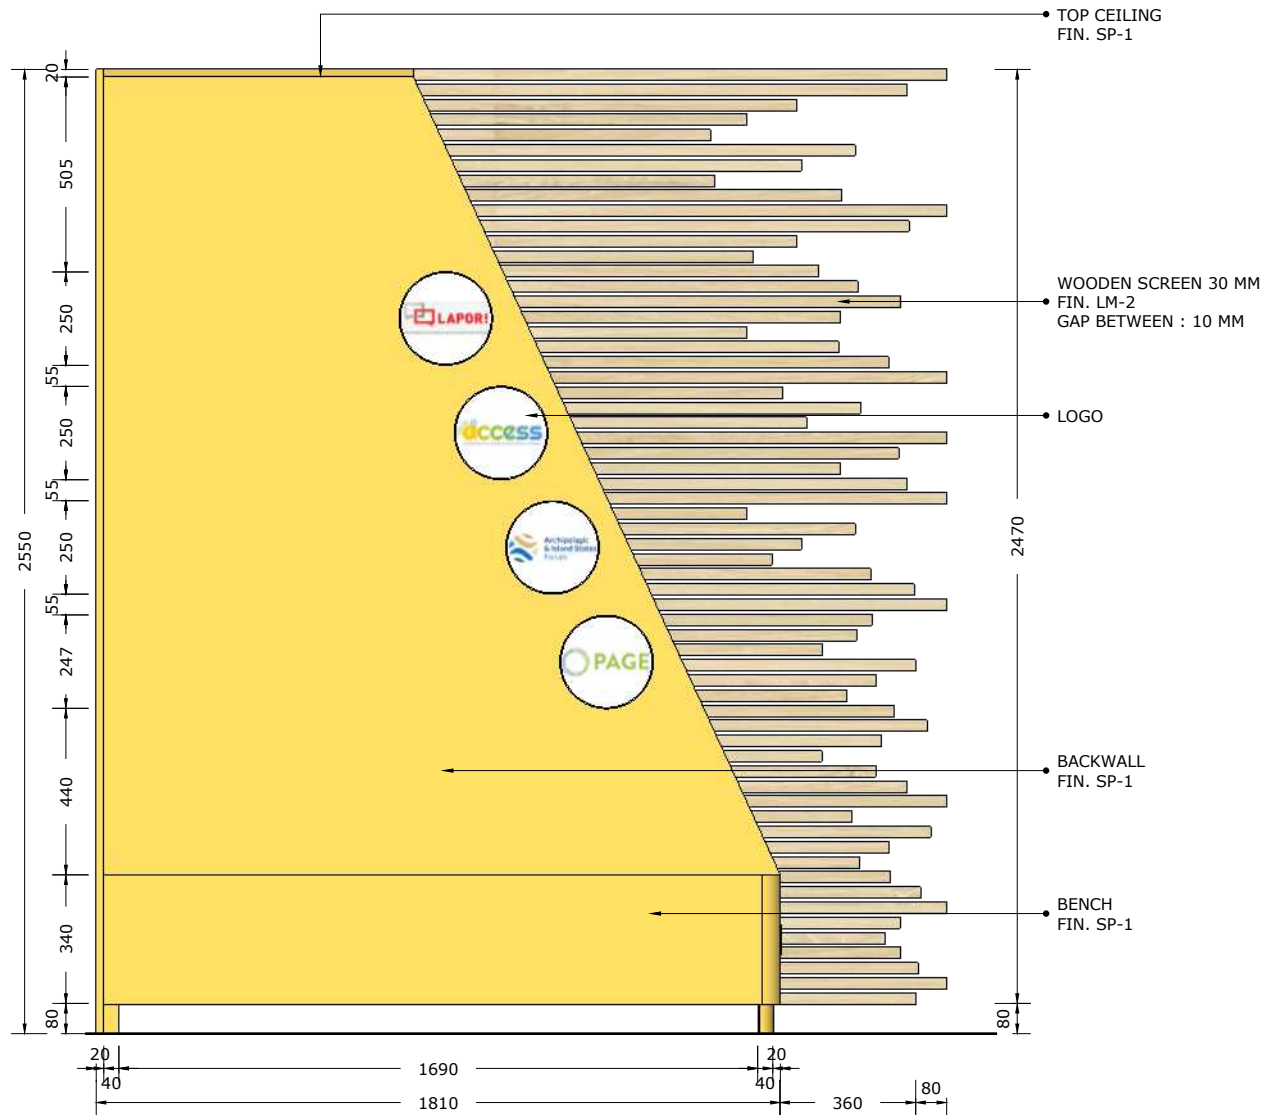

04 FRONT VIEW
INT-133 Scale: 1:20

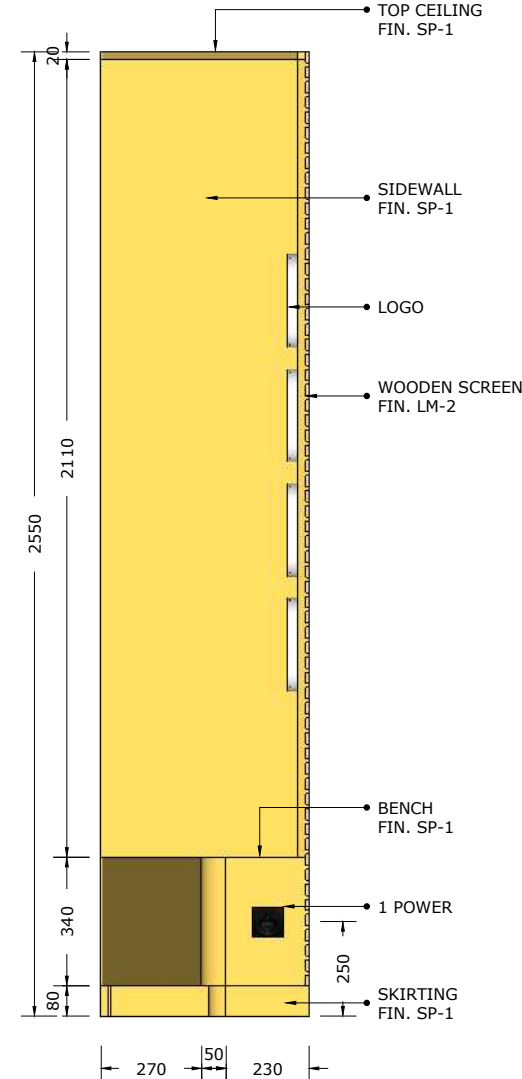

05 SIDE VIEW
INT-133 Scale: 1:20

- NOTE :
- SPC-1 : SPC FLOOR, PATINA, LEMON
SPC-2 : PATINA, SKIRTING 80
- CP-1 : SMJ CARPET, BLUESTONE, TIMELESS GREY 50 X 50 CM
CP-2 : SMJ CARPET, CONCEPT LOOP, BLUE SCREEN 50 X 50 CM
CP-3 : SMJ CARPET, COLOR BOX, YELLOW LEMON 50 X 50 CM
CP-4 : VOXFLO, PRISM 01, HEXAGONS 50x43,3 CM
CP-5 : VOXFLO, PRISM 33, HEXAGONS 50x43,3 CM
CP-6 : VOXFLO, CRYSTAL 04 HEXAGONS 50x43,3 CM
CP-7 : VOXFLO, CRYSTAL 10 HEXAGONS 50x43,3 CM
- MT-1 : STAINLESS STEEL HAIRLINE H 80 MM
MT-2 : POWDER COATING METAL, BLACK, DOFF
MT-3 : POWDER COATING METAL, WHITE, DOFF
- PT-1 : PAINT, DULUX XXX
- SP-1 : SPRAY PAINT (DUCCO) YELLOW
SP-2 : SPRAY PAINT (DUCCO) BLUE
SP-3 : SPRAY PAINT (DUCCO) TOSCA
- FB-1 : FABRIC, ATEJA LORENZIA, FESTUS 160
FB-2 : FABRIC, ATEJA LORENZIA, COLOR MATCH TO LM-4
FB-3 : FABRIC, VANIA, FORTE
- GL-1 : CLEAR GLASS
- BG-1 : BACKPAINTED GLASS, HIMALAYA ABADI - GLASSTONE - SUPER WHITE
- LM-1 : HPL, AICA AS-14062CS83 LIGHTGRAY LEGER STONE
LM-2 : HPL, CARTA CT 7878 T ARGENTINA CHERRY
LM-3 : HPL, TACO TH 006 AA MIDNIGHT GREY
LM-4 : HPL, TACO TH 021 AA CANARY YELLOW
- SF-1 : STICKER PRINTING, DOFF
SF-2 : ACRYLIC LASER CU FIN. IN SPRAY PAINT, DOFF
SF-3 : GRADATION STICKER ONE SIDE - WHITE
SF-4 : STICKER FILM GREY 40%

Bintaro Business Centre Building
Jl. RC Veteran No. 1-1 Bintaro
Phone: +62 21 7357679
Fax: +62 21 7433946
www.dezanstudio.com
admin@dezanstudio.com

CLIENT

UNDP


PROJECT

2019 - UNDP PROJECT 3A


DRAWING TITLE

J-7 BENCH


DRAWING No.	REVISION
INT-133	REV A
SCALE 1:20 @A3	CHECKED AS
DATE November 5, 2020	DRAWN AS

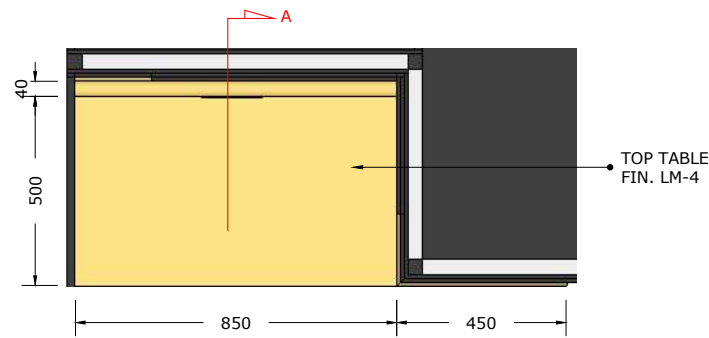


03 TOP VIEW
INT-134 Scale: 1:20

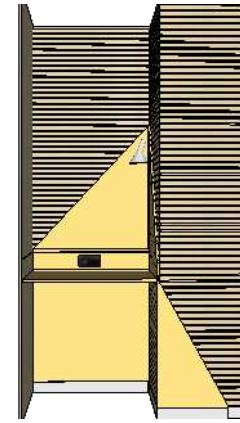


02 J-8A QUIET TABLE 1
INT-134 Scale: NTS

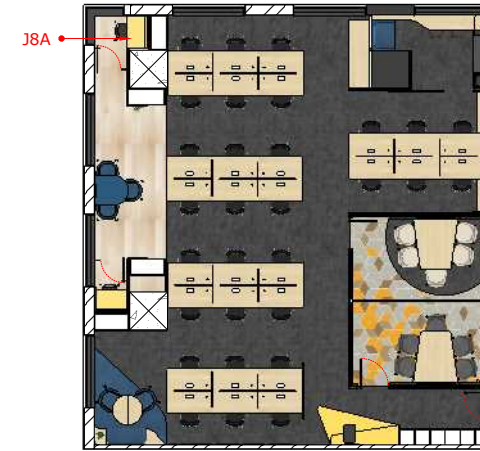


01 KEYPLAN
INT-134 Scale: 1:200

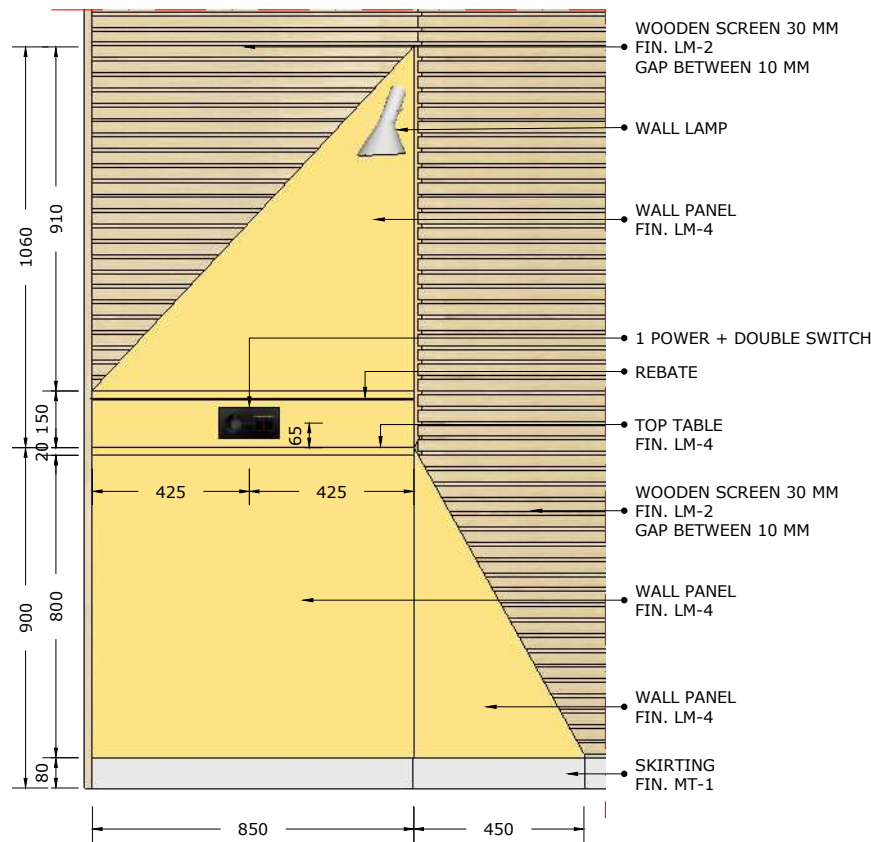

04 FRONT VIEW
INT-134 Scale: 1:20

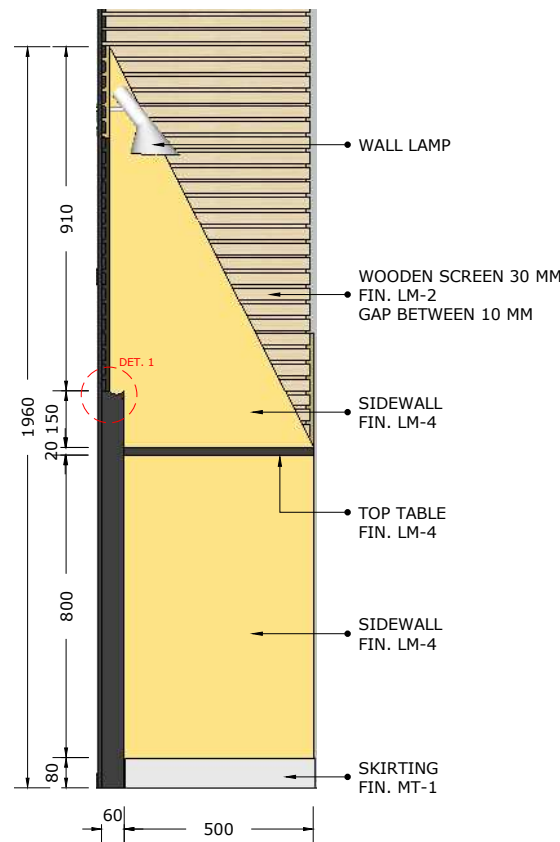

05 SIDE VIEW
INT-134 Scale: 1:20

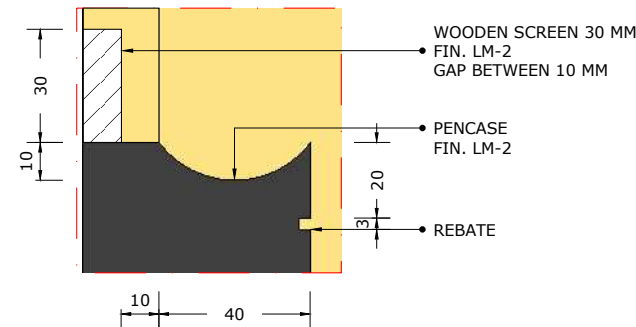


06 DETAIL 1
INT-134 Scale: 1:2


- NOTE :
- SPC-1 : SPC FLOOR, PATINA, LEMON
SPC-2 : PATINA, SKIRTING 80
- CP-1 : SMJ CARPET, BLUESTONE, TIMELESS GREY 50 X 50 CM
CP-2 : SMJ CARPET, CONCEPT LOOP, BLUE SCREEN 50 X 50 CM
CP-3 : SMJ CARPET, COLOR BOX, YELLOW LEMON 50 X 50 CM
CP-4 : VOXFLO, PRISM 01, HEXAGONS 50x43,3 CM
CP-5 : VOXFLO, PRISM 33, HEXAGONS 50x43,3 CM
CP-6 : VOXFLO, CRYSTAL 04 HEXAGONS 50x43,3 CM
CP-7 : VOXFLO, CRYSTAL 10 HEXAGONS 50x43,3 CM
- MT-1 : STAINLESS STEEL HAIRLINE H 80 MM
MT-2 : POWDER COATING METAL, BLACK, DOFF
MT-3 : POWDER COATING METAL, WHITE, DOFF
- PT-1 : PAINT, DULUX XXX
- SP-1 : SPRAY PAINT (DUCCO) YELLOW
SP-2 : SPRAY PAINT (DUCCO) BLUE
SP-3 : SPRAY PAINT (DUCCO) TOSCA
- FB-1 : FABRIC, ATEJA LORENZIA, FESTUS 160
FB-2 : FABRIC, ATEJA LORENZIA, COLOR MATCH TO LM-4
FB-3 : FABRIC, VANIA, FORTE
- GL-1 : CLEAR GLASS
- BG-1 : BACKPAINTED GLASS, HIMALAYA ABADI - GLASSTONE - SUPER WHITE
- LM-1 : HPL, AICA AS-14062CS83 LIGHTGRAY LEGER STONE
LM-2 : HPL, CARTA CT 7878 T ARGENTINA CHERRY
LM-3 : HPL, TACO TH 006 AA MIDNIGHT GREY
LM-4 : HPL, TACO TH 021 AA CANARY YELLOW
- SF-1 : STICKER PRINTING, DOFF
SF-2 : ACRYLIC LASER CU FIN. IN SPRAY PAINT, DOFF
SF-3 : GRADATION STICKER ONE SIDE - WHITE
SF-4 : STICKER FILM GREY 40%

Bintaro Business Centre Building
Jl. RC Veteran No. 1-1 Bintaro
Phone: +62 21 7357679
Fax: +62 21 7433946
www.dezanstudio.com
admin@dezanstudio.com


CLIENT	
UNDP	
PROJECT	
2019 - UNDP PROJECT 3A	
DRAWING TITLE	
J-8A QUIET TABLE 1	
DRAWING No.	REVISION
INT-134	REV A
SCALE 1:20 @A3	CHECKED AS
DATE November 5, 2020	DRAWN AS

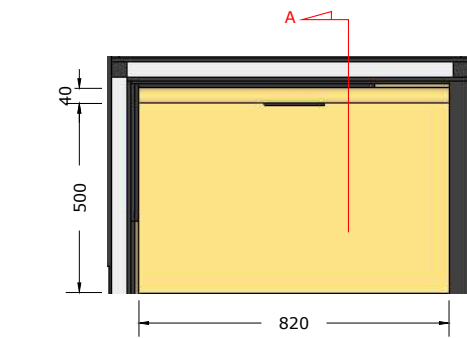


03 TOP VIEW
INT-135 Scale: 1:20

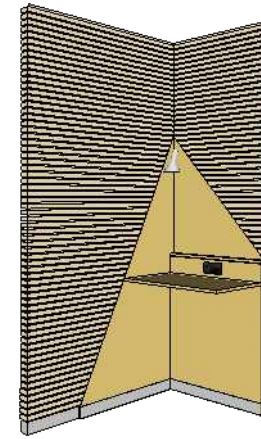


02 J-8B QUIET TABLE 2
INT-135 Scale: NTS

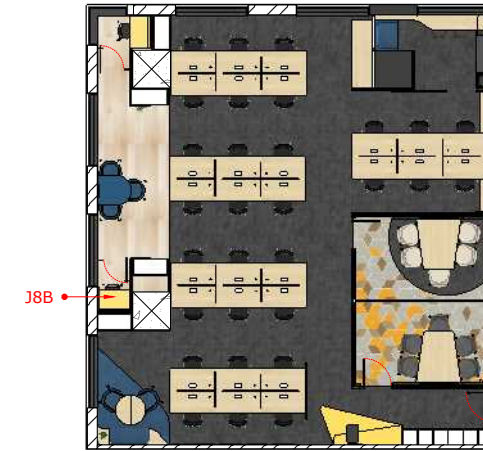


01 KEYPLAN
INT-135 Scale: 1:200

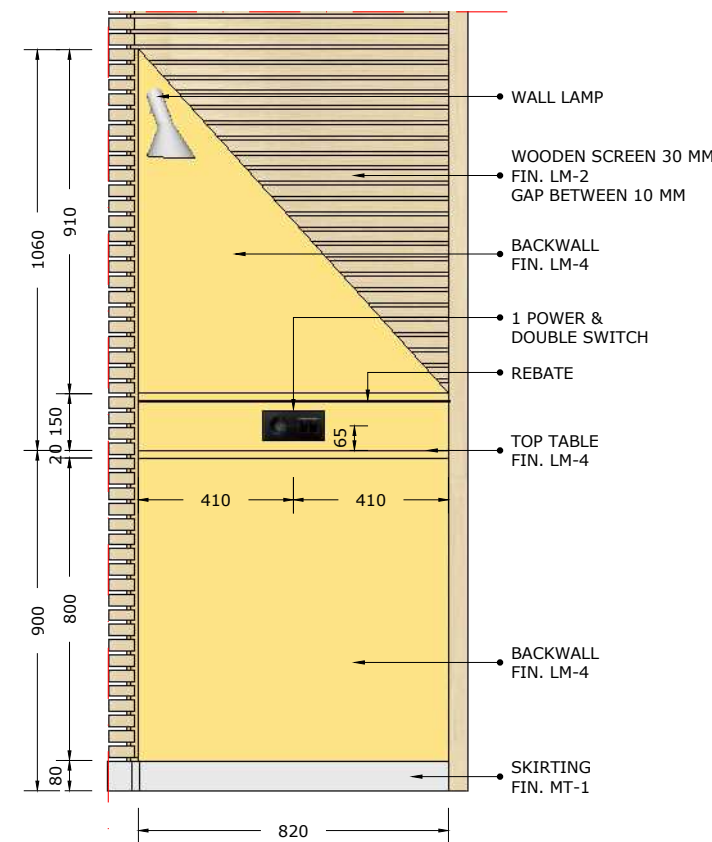

04 FRONT VIEW
INT-135 Scale: 1:20

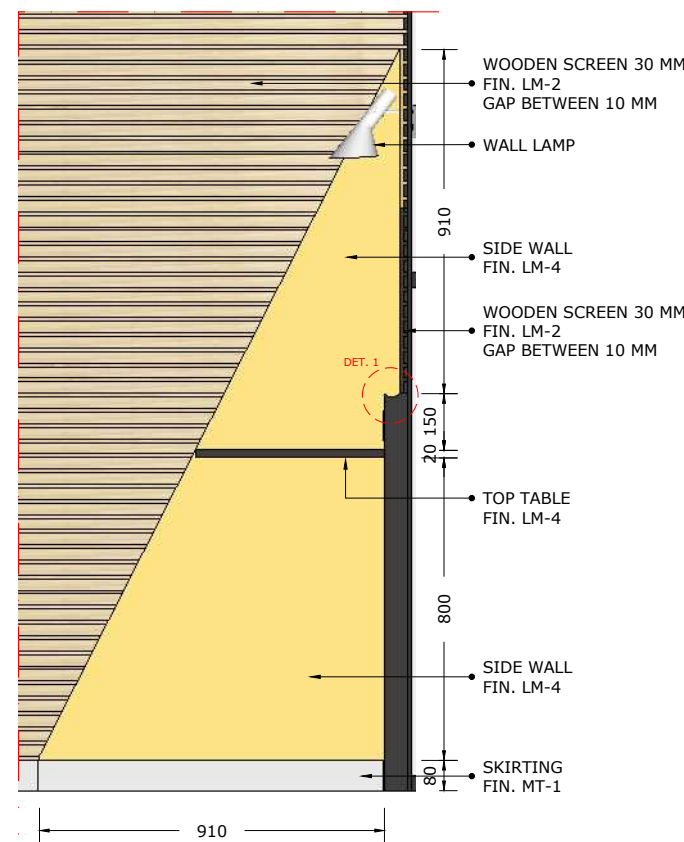

05 SIDE VIEW
INT-135 Scale: 1:20

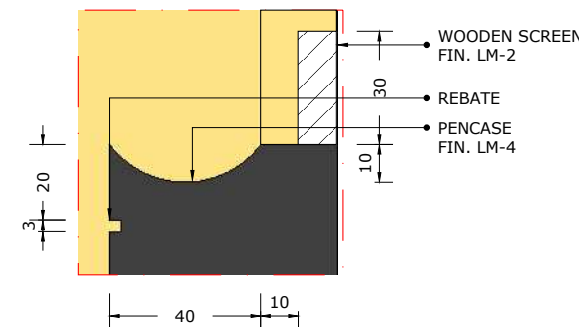

06 DETAIL 1
INT-135 Scale: 1:2

- NOTE :
- SPC-1 : SPC FLOOR, PATINA, LEMON
SPC-2 : PATINA, SKIRTING 80
- CP-1 : SMJ CARPET, BLUESTONE, TIMELESS GREY 50 X 50 CM
CP-2 : SMJ CARPET, CONCEPT LOOP, BLUE SCREEN 50 X 50 CM
CP-3 : SMJ CARPET, COLOR BOX, YELLOW LEMON 50 X 50 CM
CP-4 : VOXFLO, PRISM 01, HEXAGONS 50x43,3 CM
CP-5 : VOXFLO, PRISM 33, HEXAGONS 50x43,3 CM
CP-6 : VOXFLO, CRYSTAL 04 HEXAGONS 50x43,3 CM
CP-7 : VOXFLO, CRYSTAL 10 HEXAGONS 50x43,3 CM
- MT-1 : STAINLESS STEEL HAIRLINE H 80 MM
MT-2 : POWDER COATING METAL, BLACK, DOFF
MT-3 : POWDER COATING METAL, WHITE, DOFF
- PT-1 : PAINT, DULUX XXX
- SP-1 : SPRAY PAINT (DUCO) YELLOW
SP-2 : SPRAY PAINT (DUCO) BLUE
SP-3 : SPRAY PAINT (DUCO) TOSCA
- FB-1 : FABRIC, ATEJA LORENZIA, FESTUS 160
FB-2 : FABRIC, ATEJA LORENZIA, COLOR MATCH TO LM-4
FB-3 : FABRIC, VANIA, FORTE
- GL-1 : CLEAR GLASS
- BG-1 : BACKPAINTED GLASS, HIMALAYA ABADI - GLASSTONE - SUPER WHITE
- LM-1 : HPL, AICA AS-14062CS83 LIGHTGRAY LEGER STONE
LM-2 : HPL, CARTA CT 7878 T ARGENTINA CHERRY
LM-3 : HPL, TACO TH 006 AA MIDNIGHT GREY
LM-4 : HPL, TACO TH 021 AA CANARY YELLOW
- SF-1 : STICKER PRINTING, DOFF
SF-2 : ACRYLIC LASER CU FIN. IN SPRAY PAINT, DOFF
SF-3 : GRADATION STICKER ONE SIDE - WHITE
SF-4 : STICKER FILM GREY 40%

Bintaro Business Centre Building
Jl. RC Veteran No. 1-1 Bintaro
Phone: +62 21 7357679
Fax: +62 21 7433946
www.dezanstudio.com
admin@dezanstudio.com

CLIENT

UNDP


PROJECT

2019 - UNDP PROJECT 3A


DRAWING TITLE

J-8B QUIET TABLE 2

DRAWING No.	REVISION
INT-135	REV A
SCALE 1:20 @A3	CHECKED AS
DATE November 5, 2020	DRAWN AS

 


03 TOP VIEW
INT-136 Scale: 1:20

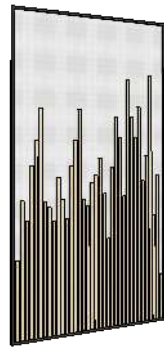


02 J-9 DIVIDER
INT-136 Scale: NTS



01 KEYPLAN
INT-136 Scale: 1:200

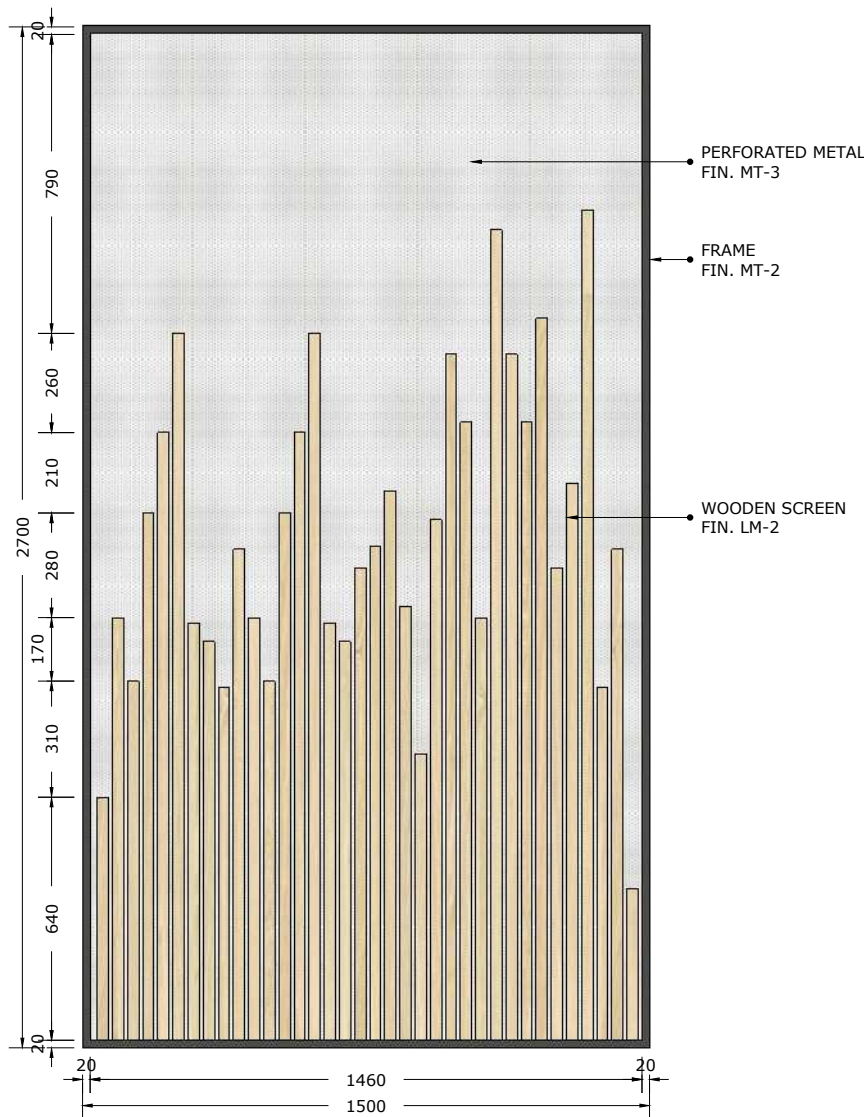

04 FRONT VIEW
INT-136 Scale: 1:20

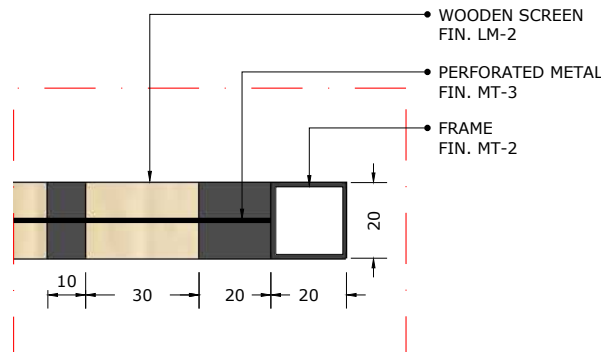


05 DETAIL 1
INT-136 Scale: 1:2


- NOTE :
- SPC-1 : SPC FLOOR, PATINA, LEMON
SPC-2 : PATINA, SKIRTING 80
- CP-1 : SMJ CARPET, BLUESTONE, TIMELESS GREY 50 X 50 CM
CP-2 : SMJ CARPET, CONCEPT LOOP, BLUE SCREEN 50 X 50 CM
CP-3 : SMJ CARPET, COLOR BOX, YELLOW LEMON 50 X 50 CM
CP-4 : VOXFLO, PRISM 01, HEXAGONS 50x43,3 CM
CP-5 : VOXFLO, PRISM 33, HEXAGONS 50x43,3 CM
CP-6 : VOXFLO, CRYSTAL 04 HEXAGONS 50x43,3 CM
CP-7 : VOXFLO, CRYSTAL 10 HEXAGONS 50x43,3 CM
- MT-1 : STAINLESS STEEL HAIRLINE H 80 MM
MT-2 : POWDER COATING METAL, BLACK, DOFF
MT-3 : POWDER COATING METAL, WHITE, DOFF
- PT-1 : PAINT, DULUX XXX
- SP-1 : SPRAY PAINT (DUCO) YELLOW
SP-2 : SPRAY PAINT (DUCO) BLUE
SP-3 : SPRAY PAINT (DUCO) TOSCA
- FB-1 : FABRIC, ATEJA LORENZIA, FESTUS 160
FB-2 : FABRIC, ATEJA LORENZIA, COLOR MATCH TO LM-4
FB-3 : FABRIC, VANIA, FORTE
- GL-1 : CLEAR GLASS
- BG-1 : BACKPAINTED GLASS, HIMALAYA ABADI - GLASSTONE - SUPER WHITE
- LM-1 : HPL, AICA AS-14062CS83 LIGHTGRAY LEGER STONE
LM-2 : HPL, CARTA CT 7878 T ARGENTINA CHERRY
LM-3 : HPL, TACO TH 006 AA MIDNIGHT GREY
LM-4 : HPL, TACO TH 021 AA CANARY YELLOW
- SF-1 : STICKER PRINTING, DOFF
SF-2 : ACRYLIC LASER CU FIN. IN SPRAY PAINT, DOFF
SF-3 : GRADATION STICKER ONE SIDE - WHITE
SF-4 : STICKER FILM GREY 40%

Bintaro Business Centre Building
Jl. RC Veteran No. 1-1 Bintaro
Phone: +62 21 7357679
Fax: +62 21 7433946
www.dezanstudio.com
admin@dezanstudio.com

CLIENT	
UNDP	
PROJECT	
2019 - UNDP PROJECT 3A	
DRAWING TITLE	
J-9 DIVIDER	
DRAWING No.	REVISION
INT-136	REV A
SCALE 1:20 @A3	CHECKED AS
DATE November 5, 2020	DRAWN AS

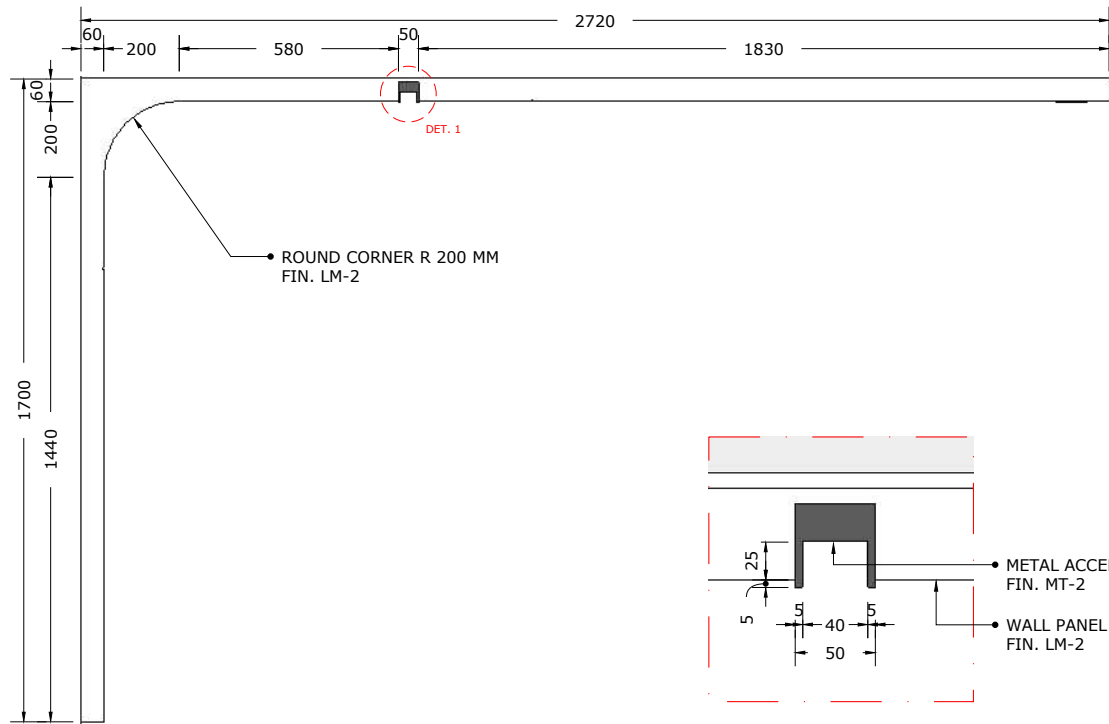

03 TOP VIEW
INT-137 Scale: 1:20

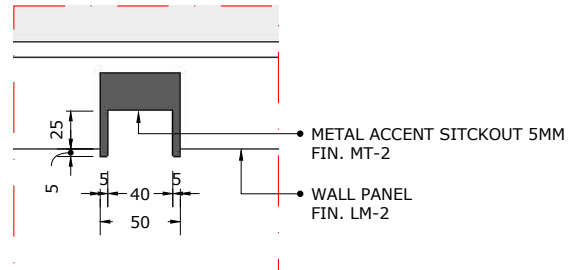

06 DETAIL 1
INT-137 Scale: 1:5




02 J-10 WALL PANEL MEETING 1
INT-137 Scale: NTS




01 KEYPLAN
INT-137 Scale: 1:200

- NOTE :
- SPC-1 : SPC FLOOR, PATINA, LEMON
SPC-2 : PATINA, SKIRTING 80
- CP-1 : SMJ CARPET, BLUESTONE, TIMELESS GREY 50 X 50 CM
CP-2 : SMJ CARPET, CONCEPT LOOP, BLUE SCREEN 50 X 50 CM
CP-3 : SMJ CARPET, COLOR BOX, YELLOW LEMON 50 X 50 CM
CP-4 : VOXFLO, PRISM 01, HEXAGONS 50x43,3 CM
CP-5 : VOXFLO, PRISM 33, HEXAGONS 50x43,3 CM
CP-6 : VOXFLO, CRYSTAL 04 HEXAGONS 50x43,3 CM
CP-7 : VOXFLO, CRYSTAL 10 HEXAGONS 50x43,3 CM
- MT-1 : STAINLESS STEEL HAIRLINE H 80 MM
MT-2 : POWDER COATING METAL, BLACK, DOFF
MT-3 : POWDER COATING METAL, WHITE, DOFF
- PT-1 : PAINT, DULUX XXX
- SP-1 : SPRAY PAINT (DUCO) YELLOW
SP-2 : SPRAY PAINT (DUCO) BLUE
SP-3 : SPRAY PAINT (DUCO) TOSCA
- FB-1 : FABRIC, ATEJA LORENZIA, FESTUS 160
FB-2 : FABRIC, ATEJA LORENZIA, COLOR MATCH TO LM-4
FB-3 : FABRIC, VANIA, FORTE
- GL-1 : CLEAR GLASS
- BG-1 : BACKPAINTED GLASS, HIMALAYA ABADI - GLASSTONE - SUPER WHITE
- LM-1 : HPL, AICA AS-14062CS83 LIGHTGRAY LEGER STONE
LM-2 : HPL, CARTA CT 7878 T ARGENTINA CHERRY
LM-3 : HPL, TACO TH 006 AA MIDNIGHT GREY
LM-4 : HPL, TACO TH 021 AA CANARY YELLOW
- SF-1 : STICKER PRINTING, DOFF
SF-2 : ACRYLIC LASER CU FIN. IN SPRAY PAINT, DOFF
SF-3 : GRADATION STICKER ONE SIDE - WHITE
SF-4 : STICKER FILM GREY 40%

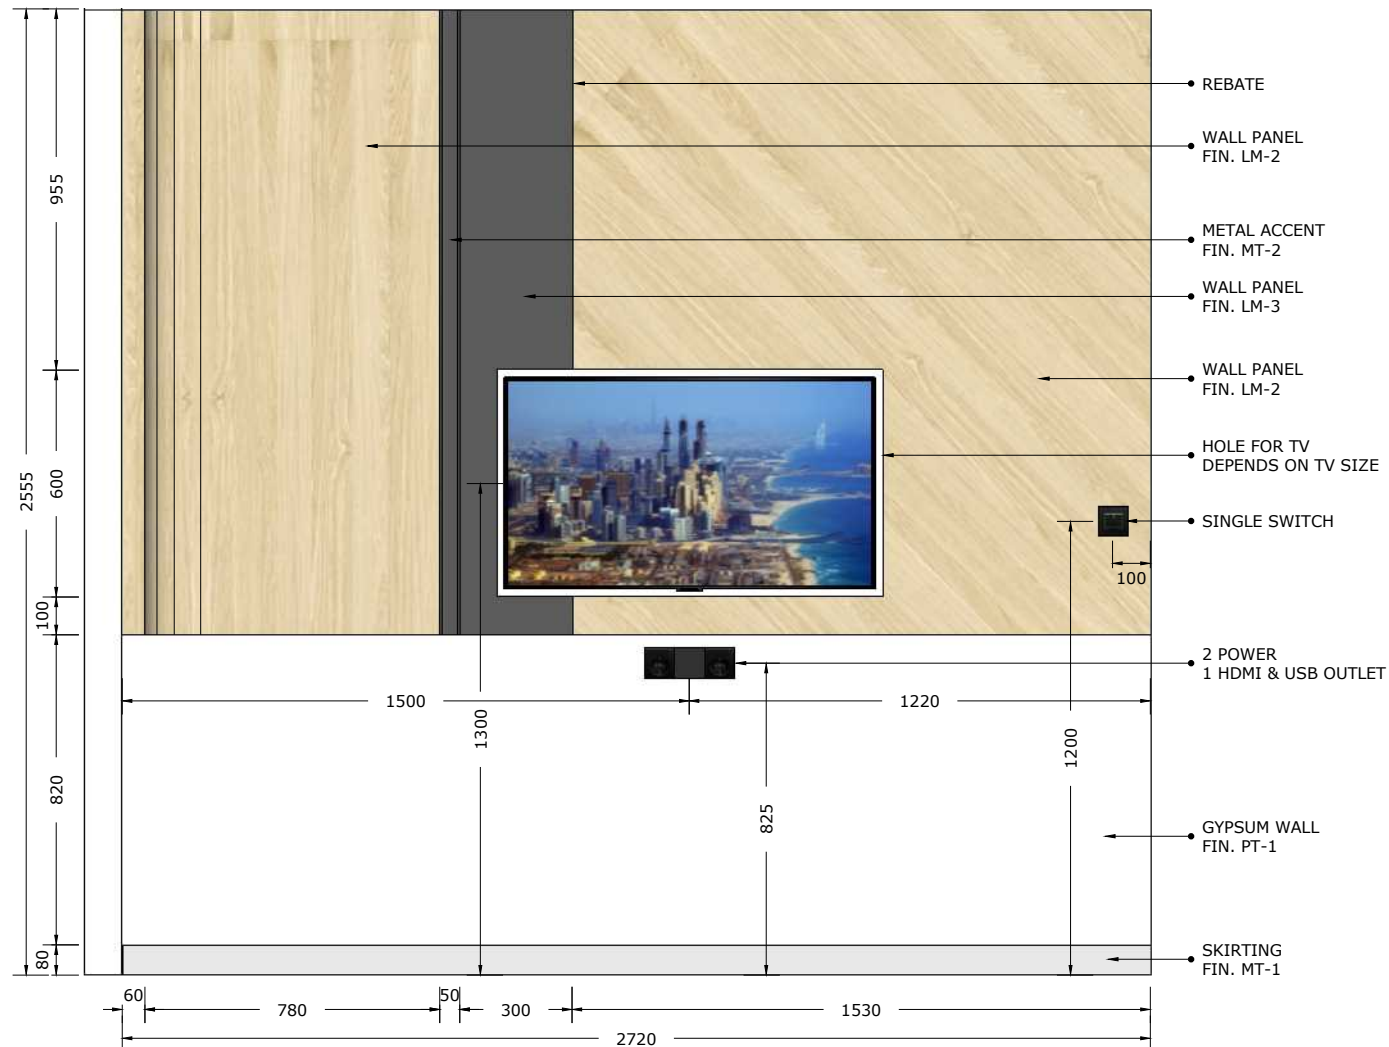

04 FRONT VIEW
INT-137 Scale: 1:20

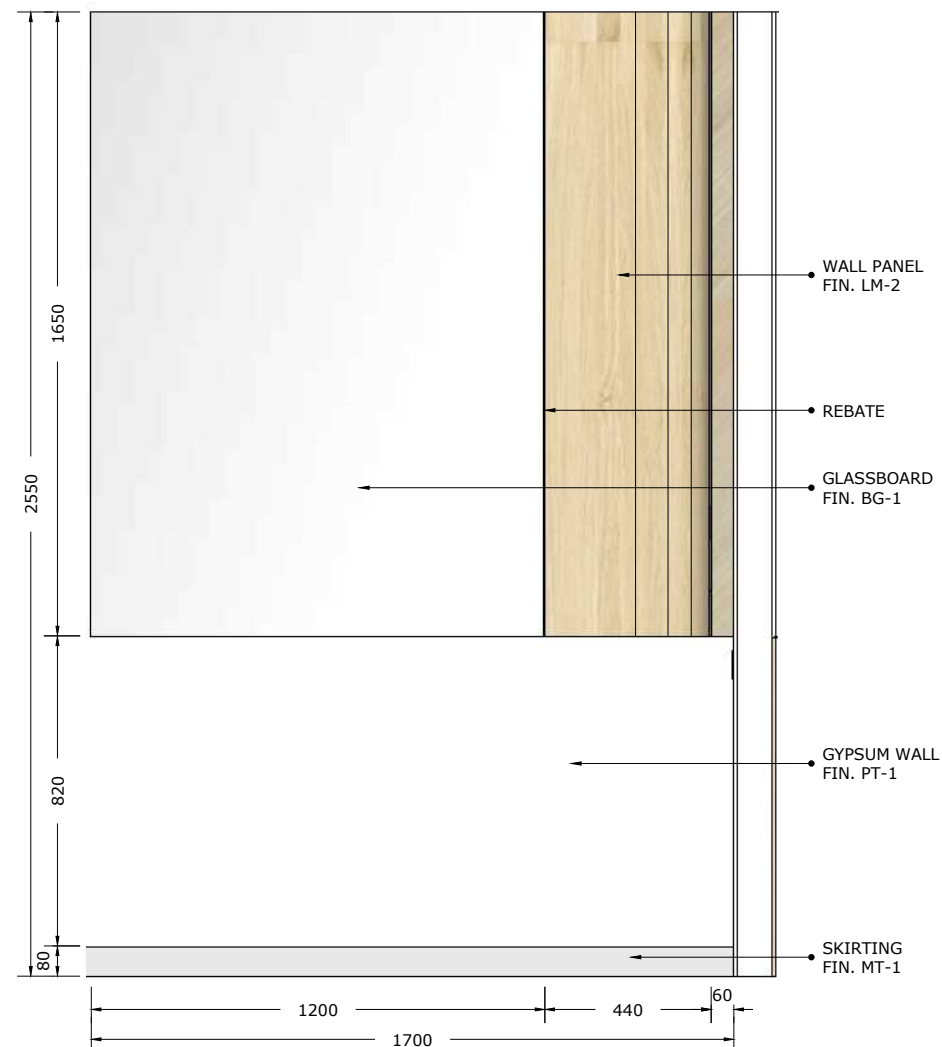

05 SIDE VIEW
INT-137 Scale: 1:20

Bintaro Business Centre Building
Jl. RC Veteran No. 1-1 Bintaro
Phone: +62 21 7357679
Fax: +62 21 7433946
www.dezanstudio.com
admin@dezanstudio.com

CLIENT

UNDP






PROJECT

2019 - UNDP PROJECT 3A

DRAWING TITLE

J-10 WALL PANEL MEETING 1

DRAWING No.	REVISION
INT-137	REV A
SCALE 1:20 @A3	CHECKED AS
DATE November 5, 2020	DRAWN AS

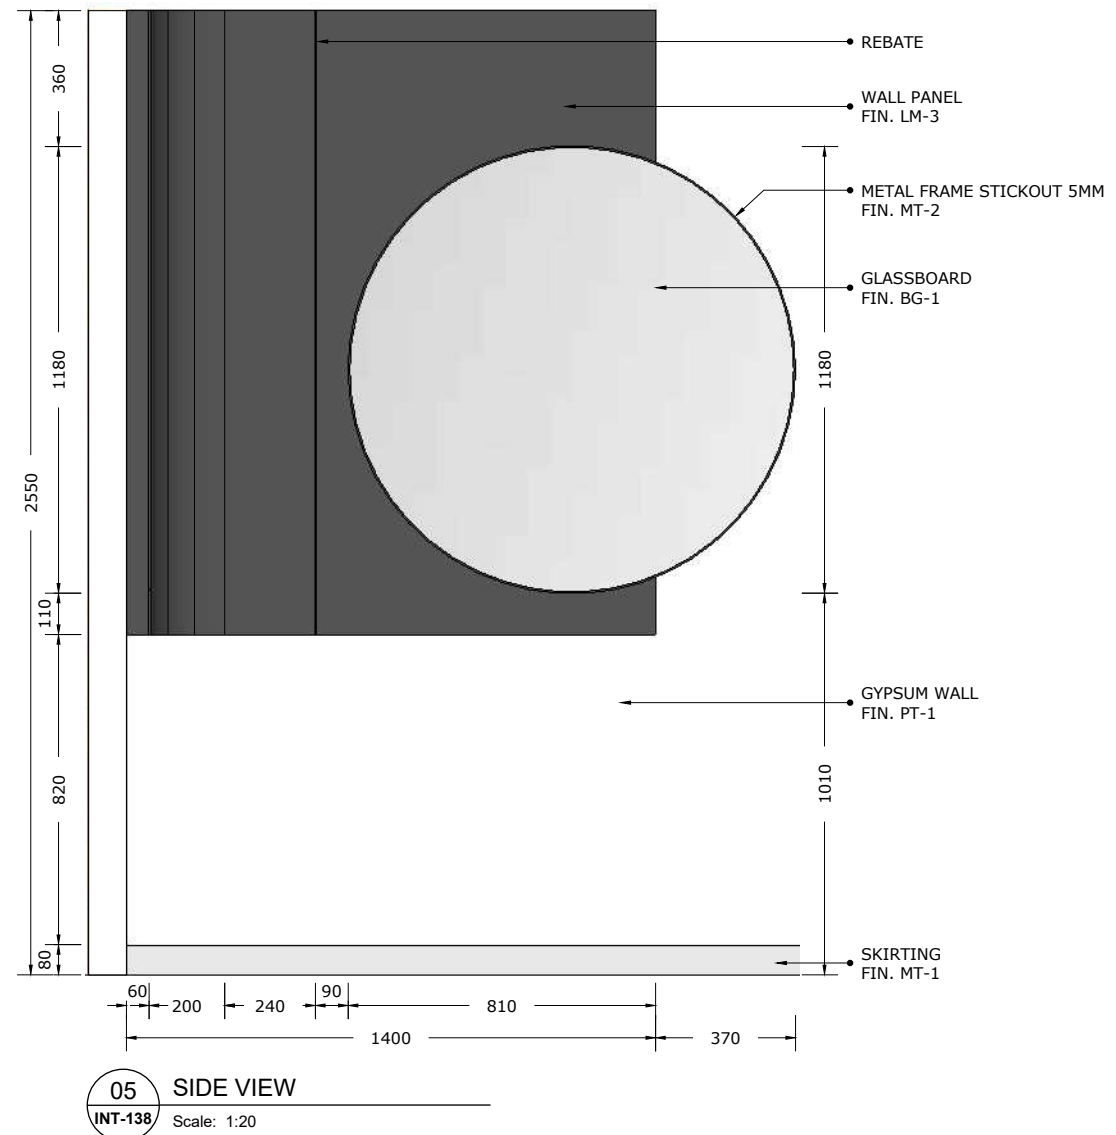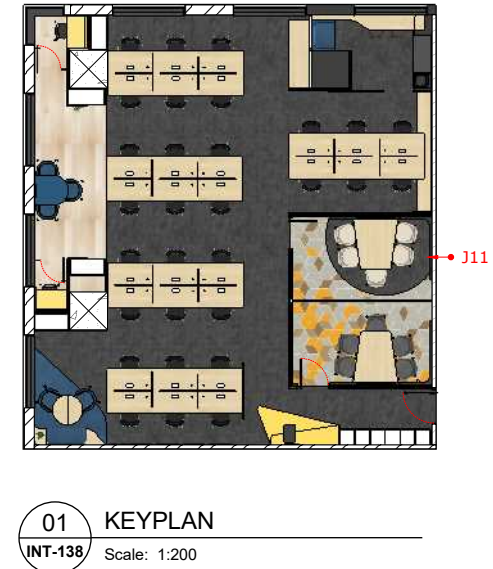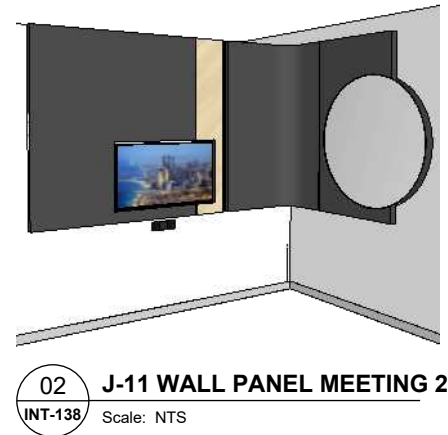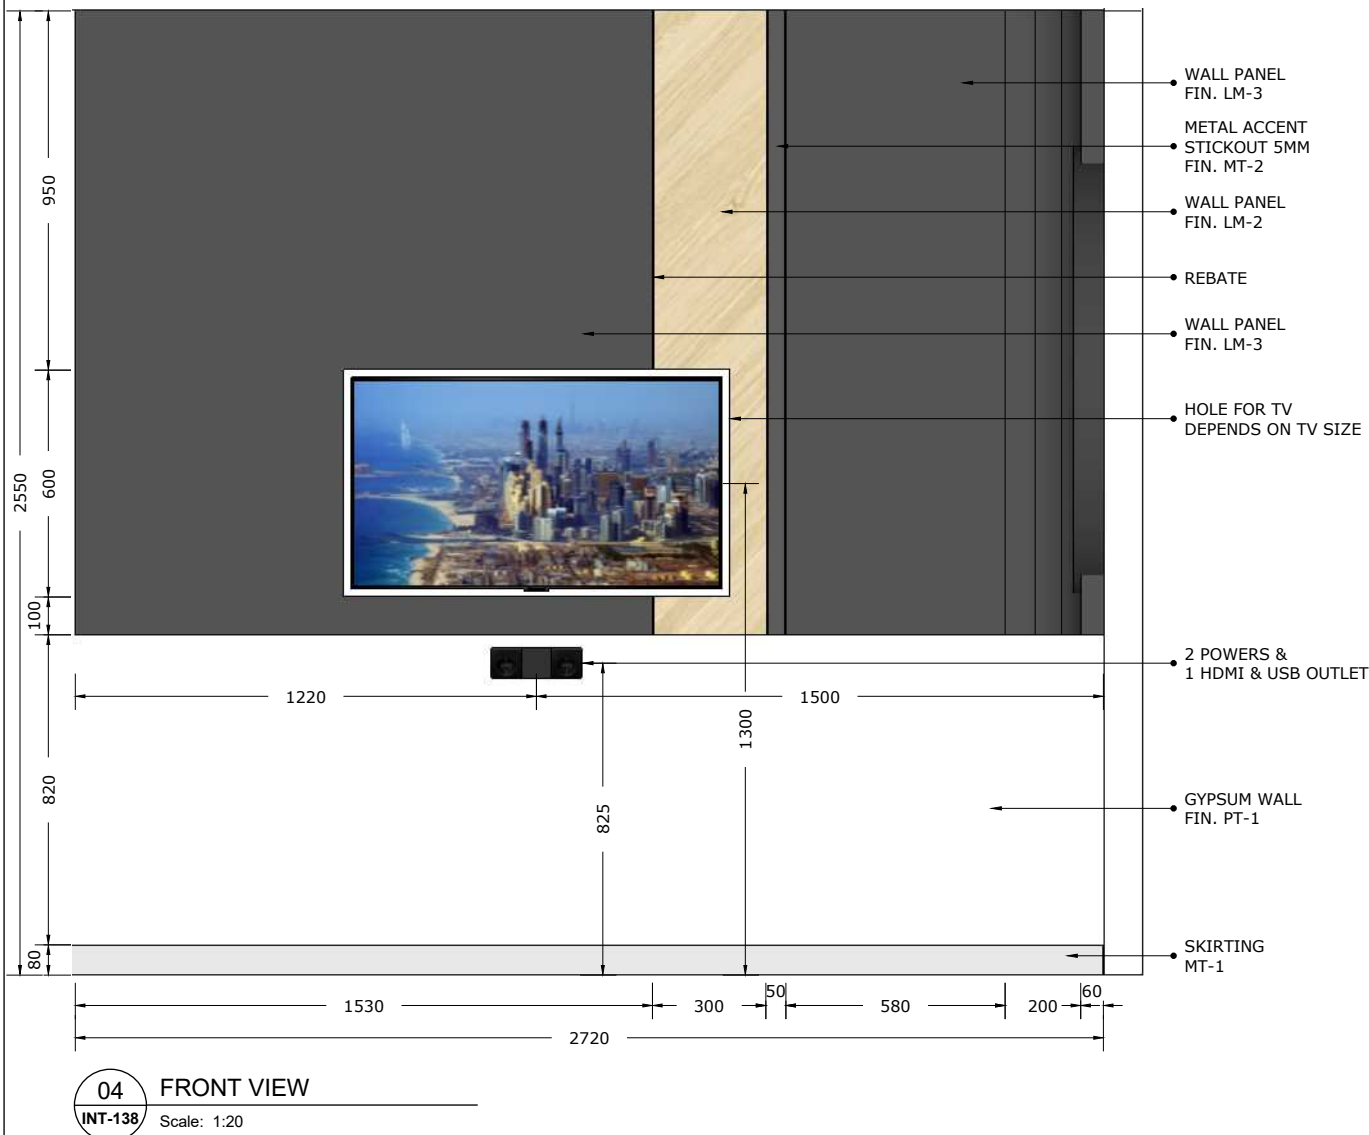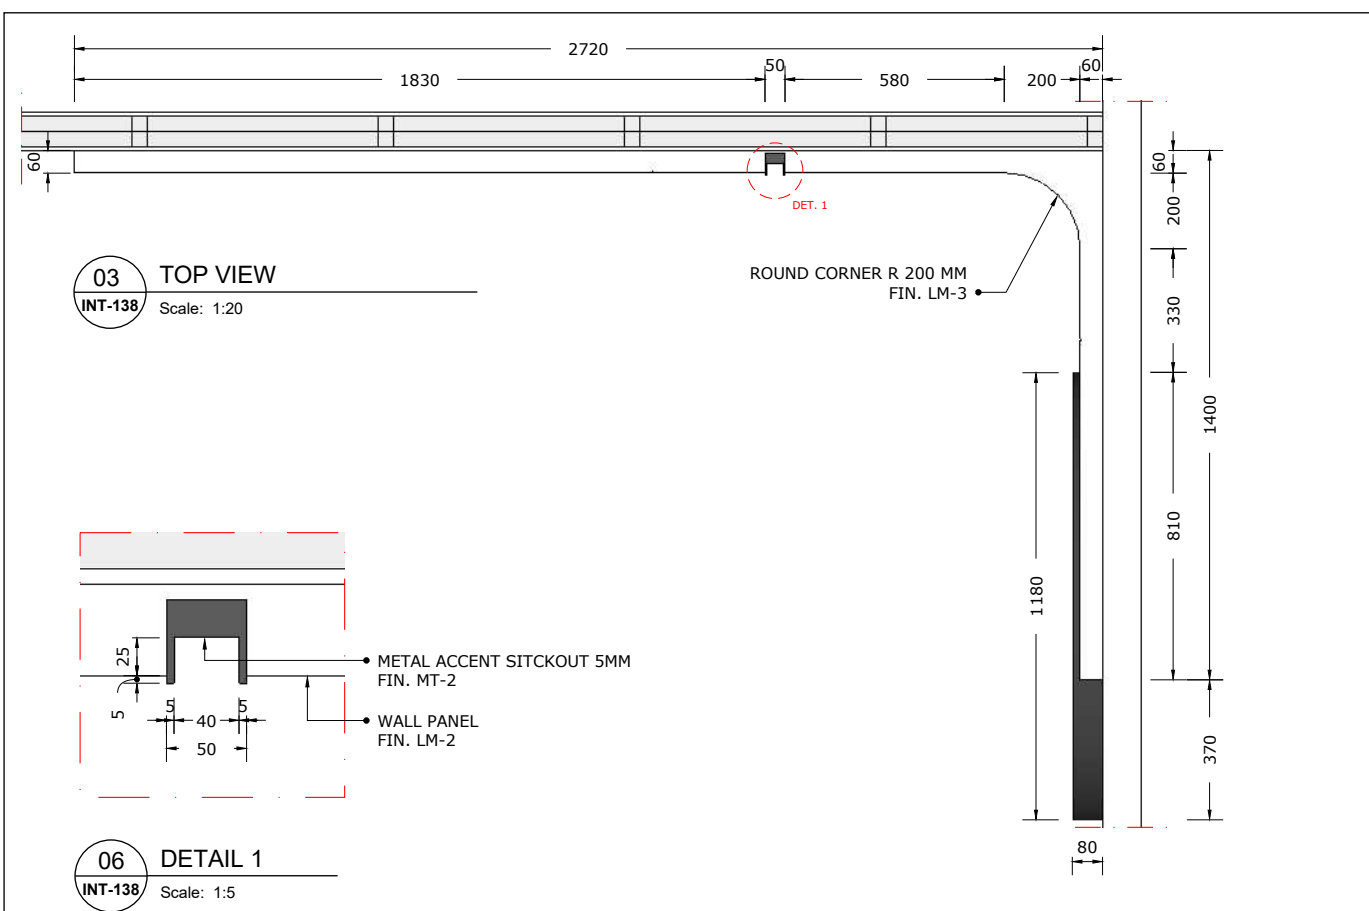

- NOTE :
- SPC-1 : SPC FLOOR, PATINA, LEMON
SPC-2 : PATINA, SKIRTING 80
- CP-1 : SMJ CARPET, BLUESTONE, TIMELESS GREY
50 X 50 CM
CP-2 : SMJ CARPET, CONCEPT LOOP, BLUE SCREEN
50 X 50 CM
CP-3 : SMJ CARPET, COLOR BOX, YELLOW LEMON
50 X 50 CM
CP-4 : VOXFLO, PRISM 01, HEXAGONS 50x43,3 CM
CP-5 : VOXFLO, PRISM 33, HEXAGONS 50x43,3 CM
CP-6 : VOXFLO, CRYSTAL 04 HEXAGONS 50x43,3 CM
CP-7 : VOXFLO, CRYSTAL 10 HEXAGONS 50x43,3 CM
- MT-1 : STAINLESS STEEL HAIRLINE H 80 MM
MT-2 : POWDER COATING METAL, BLACK, DOFF
MT-3 : POWDER COATING METAL, WHITE, DOFF
- PT-1 : PAINT, DULUX XXX
- SP-1 : SPRAY PAINT (DUCO) YELLOW
SP-2 : SPRAY PAINT (DUCO) BLUE
SP-3 : SPRAY PAINT (DUCO) TOSCA
- FB-1 : FABRIC, ATEJA LORENZIA, FESTUS 160
FB-2 : FABRIC, ATEJA LORENZIA,
COLOR MATCH TO LM-4
FB-3 : FABRIC, VANIA, FORTE
- GL-1 : CLEAR GLASS
- BG-1 : BACKPAINTED GLASS, HIMALAYA ABADI -
GLASSTONE - SUPER WHITE
- LM-1 : HPL, AICA AS-14062CS83 LIGHTGRAY LEGER
STONE
LM-2 : HPL, CARTA CT 7878 T ARGENTINA CHERRY
LM-3 : HPL, TACO TH 006 AA MIDNIGHT GREY
LM-4 : HPL, TACO TH 021 AA CANARY YELLOW
- SF-1 : STICKER PRINTING, DOFF
SF-2 : ACRYLIC LASER CU FIN. IN SPRAY PAINT, DOFF
SF-3 : GRADATION STICKER ONE SIDE - WHITE
SF-4 : STICKER FILM GREY 40%


 Bintaro Business Centre Building Jl. RC Veteran No. 1-1 Bintaro Phone: +62 21 7357679 Fax: +62 21 7433946 www.dezanstudio.com admin@dezanstudio.com	
CLIENT	
UNDP	
PROJECT	
2019 - UNDP PROJECT 3A	
DRAWING TITLE	
J-10 WALL PANEL MEETING 1	
DRAWING No.	REVISION
INT-138	REV A
SCALE	1:20 @A3
DATE	November 5, 2020
CHECKED	AS
DRAWN	AS




02 J-12 COMMUNICATION WALL
INT-139 Scale: NTS




01 KEYPLAN
INT-139 Scale: 1:200

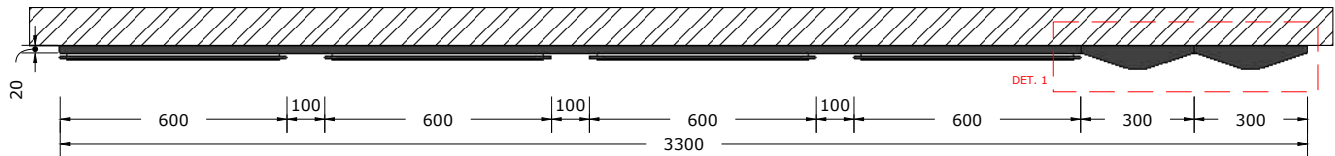

03 TOP VIEW
INT-139 Scale: 1:20

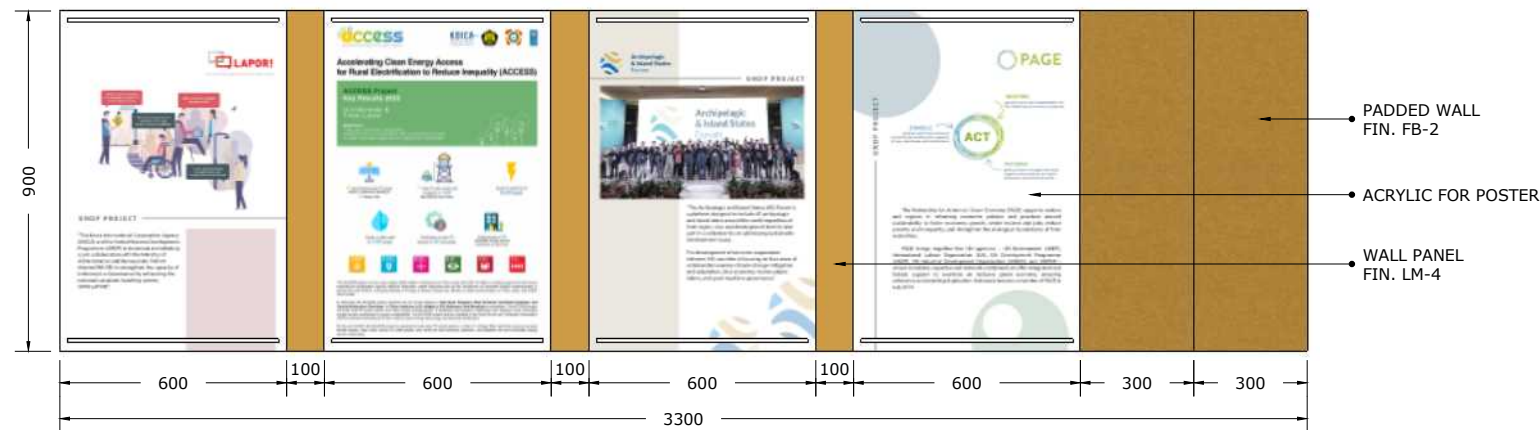

04 FRONT VIEW
INT-139 Scale: 1:20

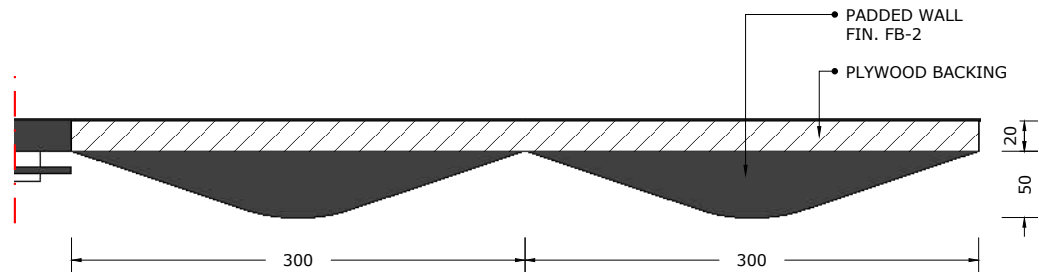

05 DETAIL 1
INT-139 Scale: 1:5

- NOTE :
- SPC-1 : SPC FLOOR, PATINA, LEMON
SPC-2 : PATINA, SKIRTING 80
- CP-1 : SMJ CARPET, BLUESTONE, TIMELESS GREY 50 X 50 CM
CP-2 : SMJ CARPET, CONCEPT LOOP, BLUE SCREEN 50 X 50 CM
CP-3 : SMJ CARPET, COLOR BOX, YELLOW LEMON 50 X 50 CM
CP-4 : VOXFLO, PRISM 01, HEXAGONS 50x43,3 CM
CP-5 : VOXFLO, PRISM 33, HEXAGONS 50x43,3 CM
CP-6 : VOXFLO, CRYSTAL 04 HEXAGONS 50x43,3 CM
CP-7 : VOXFLO, CRYSTAL 10 HEXAGONS 50x43,3 CM
- MT-1 : STAINLESS STEEL HAIRLINE H 80 MM
MT-2 : POWDER COATING METAL, BLACK, DOFF
MT-3 : POWDER COATING METAL, WHITE, DOFF
- PT-1 : PAINT, DULUX XXX
- SP-1 : SPRAY PAINT (DUCO) YELLOW
SP-2 : SPRAY PAINT (DUCO) BLUE
SP-3 : SPRAY PAINT (DUCO) TOSCA
- FB-1 : FABRIC, ATEJA LORENZIA, FESTUS 160
FB-2 : FABRIC, ATEJA LORENZIA, COLOR MATCH TO LM-4
FB-3 : FABRIC, VANIA, FORTE
- GL-1 : CLEAR GLASS
- BG-1 : BACKPAINTED GLASS, HIMALAYA ABADI - GLASSTONE - SUPER WHITE
- LM-1 : HPL, AICA AS-14062CS83 LIGHTGRAY LEGER STONE
LM-2 : HPL, CARTA CT 7878 T ARGENTINA CHERRY
LM-3 : HPL, TACO TH 006 AA MIDNIGHT GREY
LM-4 : HPL, TACO TH 021 AA CANARY YELLOW
- SF-1 : STICKER PRINTING, DOFF
SF-2 : ACRYLIC LASER CU FIN. IN SPRAY PAINT, DOFF
SF-3 : GRADATION STICKER ONE SIDE - WHITE
SF-4 : STICKER FILM GREY 40%

Bintaro Business Centre Building
Jl. RC Veteran No. 1-1 Bintaro
Phone: +62 21 7357679
Fax: +62 21 7433946
www.dezanstudio.com
admin@dezanstudio.com

CLIENT

UNDP


PROJECT

2019 - UNDP PROJECT 3A


DRAWING TITLE

J-10 WALL PANEL MEETING 1


DRAWING No.	REVISION
INT-139	REV A
SCALE	1:20 @A3
DATE	November 5, 2020
CHECKED	AS
DRAWN	AS

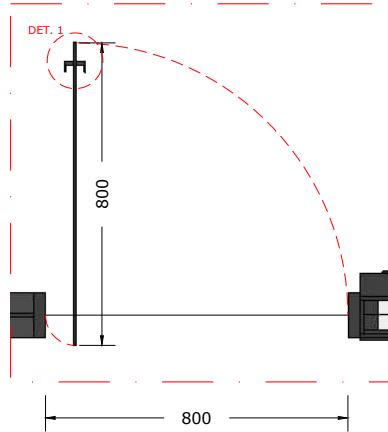


02 TOP VIEW D1
INT-140 Scale: 1:20

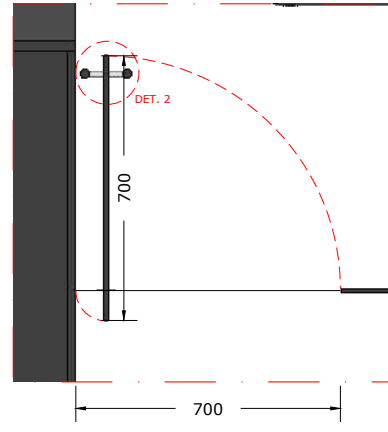


05 TOP VIEW D2
INT-140 Scale: 1:20

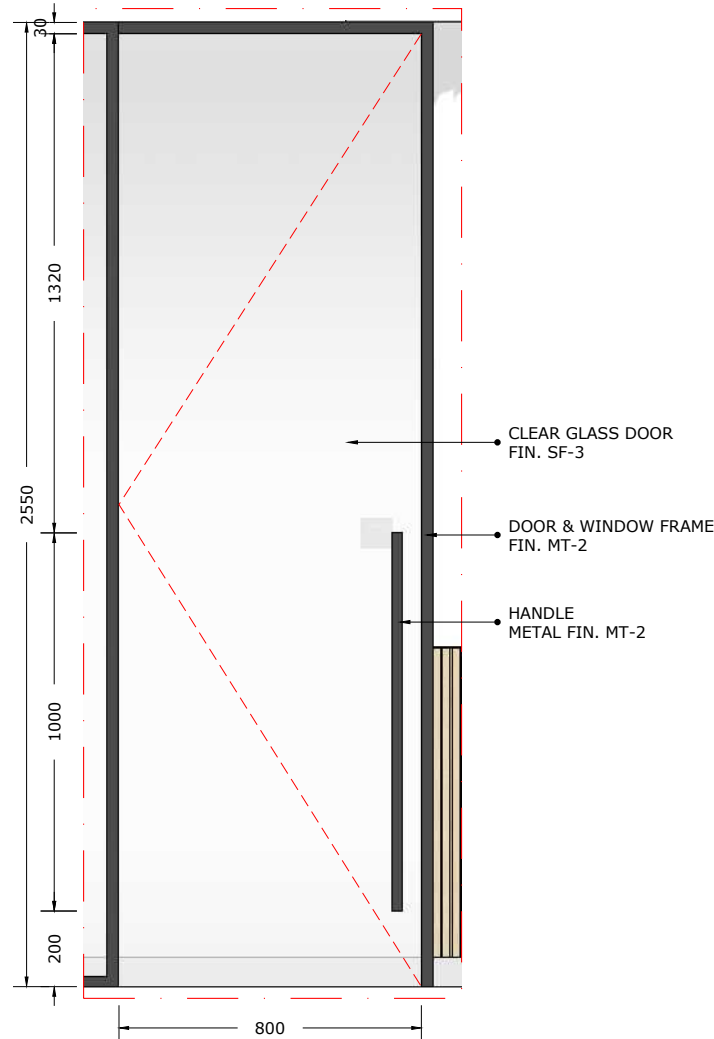


03 FRONT VIEW D1
INT-140 Scale: 1:20

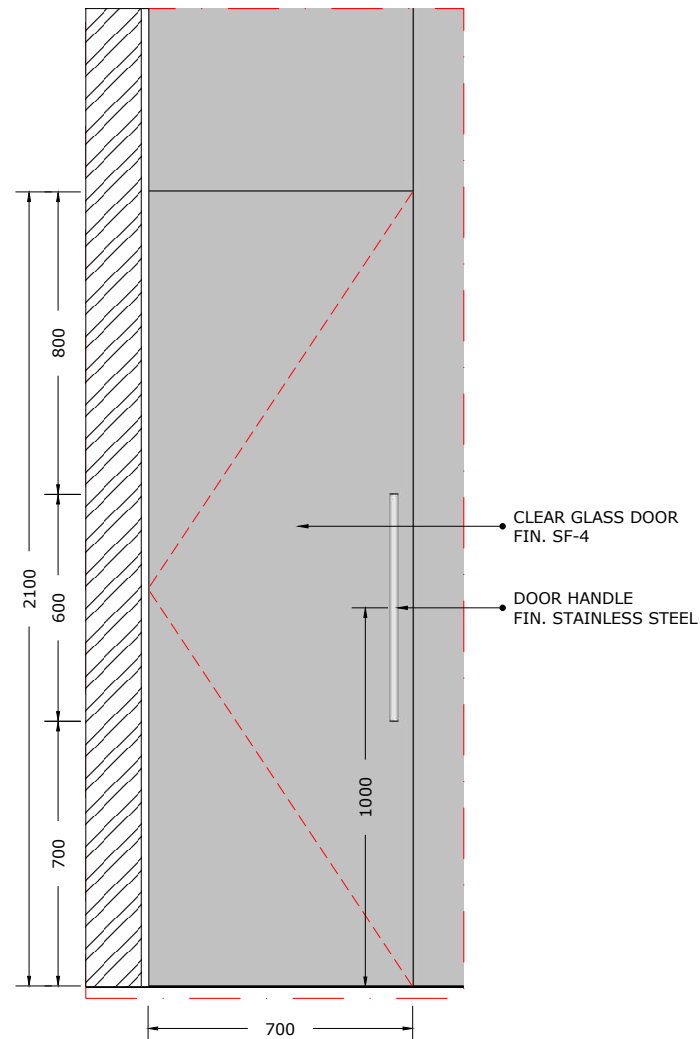


06 FRONT VIEW D2
INT-140 Scale: 1:20

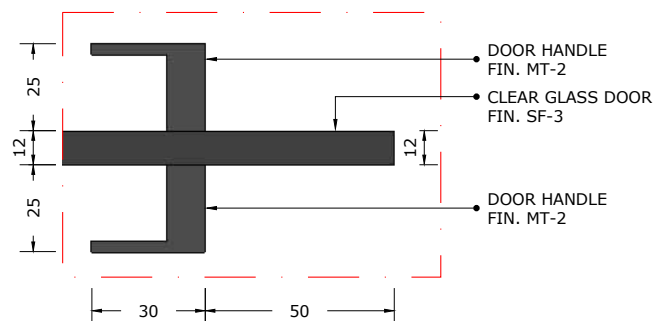

04 DETAIL 1
INT-140 Scale: 1:2

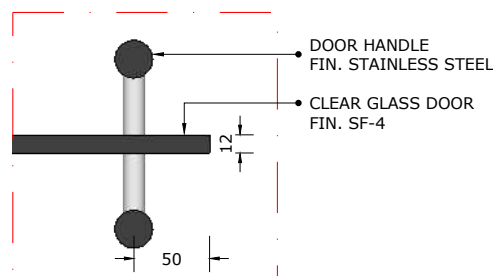

07 DETAIL 2
INT-140 Scale: 1:2

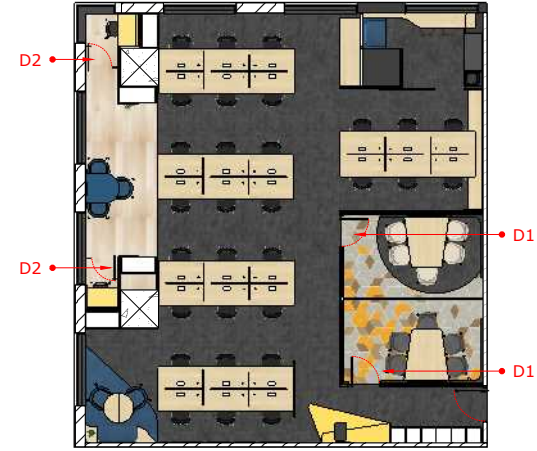

01 KEYPLAN
INT-140 Scale: 1:200

- NOTE :
- SPC-1 : SPC FLOOR, PATINA, LEMON
SPC-2 : PATINA, SKIRTING 80
- CP-1 : SMJ CARPET, BLUESTONE, TIMELESS GREY 50 X 50 CM
CP-2 : SMJ CARPET, CONCEPT LOOP, BLUE SCREEN 50 X 50 CM
CP-3 : SMJ CARPET, COLOR BOX, YELLOW LEMON 50 X 50 CM
CP-4 : VOXFLO, PRISM 01, HEXAGONS 50x43,3 CM
CP-5 : VOXFLO, PRISM 33, HEXAGONS 50x43,3 CM
CP-6 : VOXFLO, CRYSTAL 04 HEXAGONS 50x43,3 CM
CP-7 : VOXFLO, CRYSTAL 10 HEXAGONS 50x43,3 CM
- MT-1 : STAINLESS STEEL HAIRLINE H 80 MM
MT-2 : POWDER COATING METAL, BLACK, DOFF
MT-3 : POWDER COATING METAL, WHITE, DOFF
- PT-1 : PAINT, DULUX XXX
- SP-1 : SPRAY PAINT (DUCO) YELLOW
SP-2 : SPRAY PAINT (DUCO) BLUE
SP-3 : SPRAY PAINT (DUCO) TOSCA
- FB-1 : FABRIC, ATEJA LORENZIA, FESTUS 160
FB-2 : FABRIC, ATEJA LORENZIA, COLOR MATCH TO LM-4
FB-3 : FABRIC, VANIA, FORTE
- GL-1 : CLEAR GLASS
- BG-1 : BACKPAINTED GLASS, HIMALAYA ABADI - GLASSTONE - SUPER WHITE
- LM-1 : HPL, AICA AS-14062CS83 LIGHTGRAY LEGER STONE
LM-2 : HPL, CARTA CT 7878 T ARGENTINA CHERRY
LM-3 : HPL, TACO TH 006 AA MIDNIGHT GREY
LM-4 : HPL, TACO TH 021 AA CANARY YELLOW
- SF-1 : STICKER PRINTING, DOFF
SF-2 : ACRYLIC LASER CU FIN. IN SPRAY PAINT, DOFF
SF-3 : GRADATION STICKER ONE SIDE - WHITE
SF-4 : STICKER FILM GREY 40%

Bintaro Business Centre Building
Jl. RC Veteran No. 1-1 Bintaro
Phone: +62 21 7357679
Fax: +62 21 7433946
www.dezanstudio.com
admin@dezanstudio.com

CLIENT

UNDP


PROJECT

2019 - UNDP PROJECT 3A


DRAWING TITLE

D-1 MEETING DOOR
D-2 QUIET DOOR


DRAWING No.	REVISION
INT-140	REV A
SCALE 1:20 @A3	CHECKED AS
DATE November 5, 2020	DRAWN AS

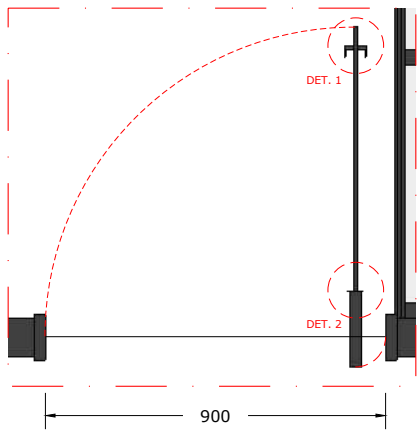


02 TOP VIEW D3
INT-141 Scale: 1:20

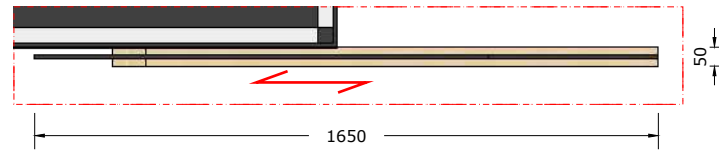


06 TOP VIEW D4
INT-141 Scale: 1:20

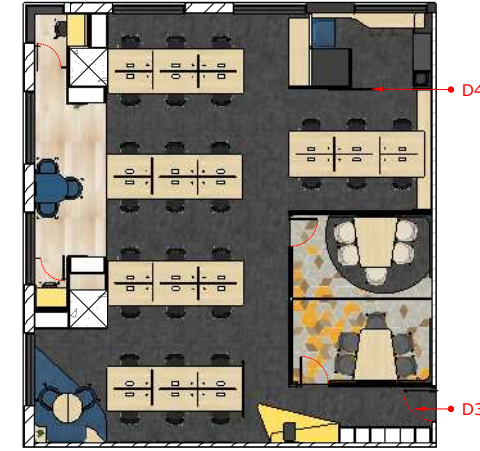


01 KEYPLAN
INT-141 Scale: 1:200

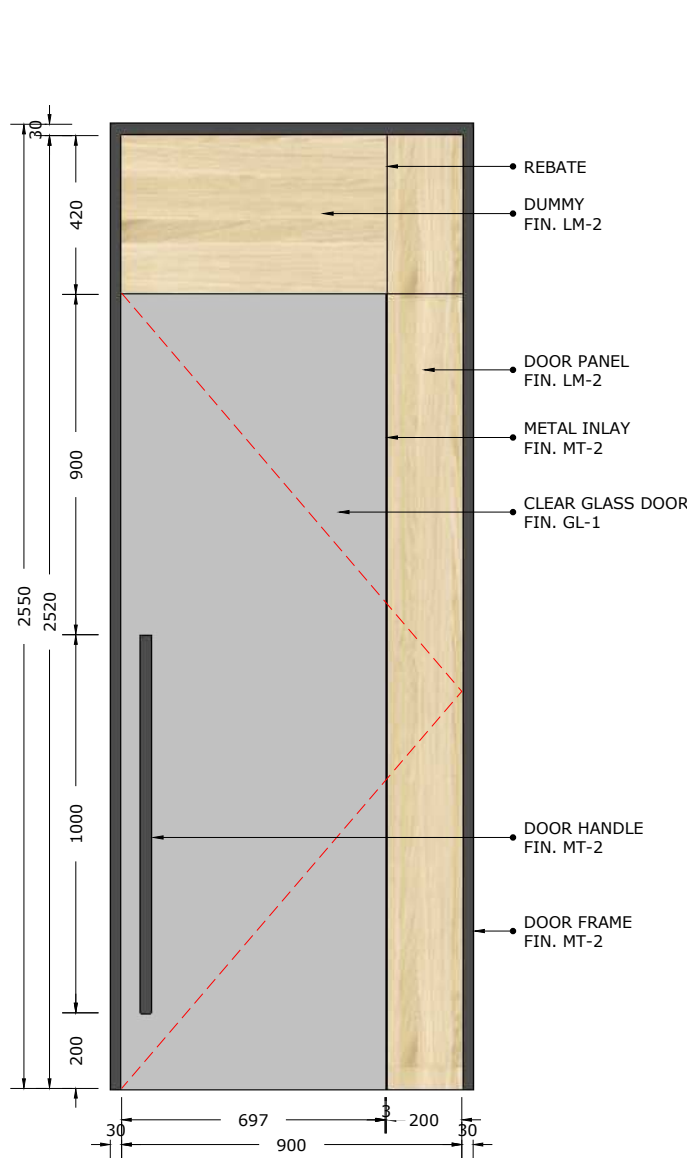


03 FRONT VIEW D2
INT-141 Scale: 1:20

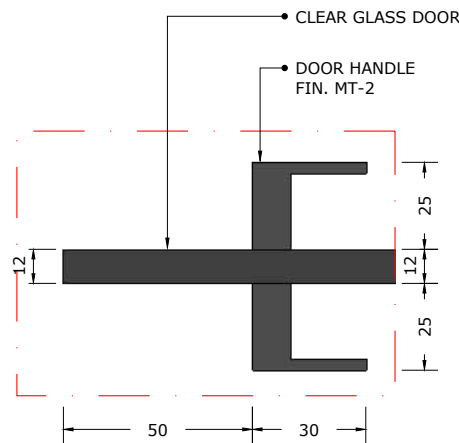

04 DETAIL 1
INT-141 Scale: 1:2

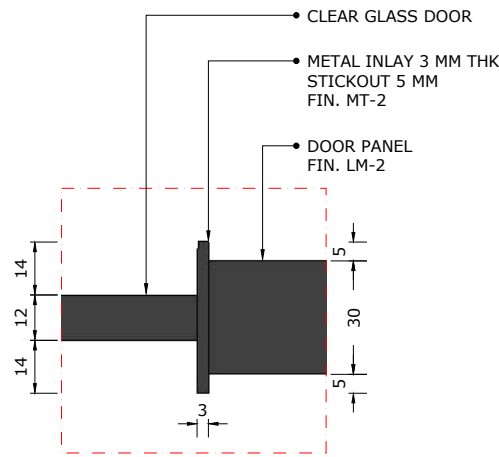

05 DETAIL 2
INT-141 Scale: 1:2

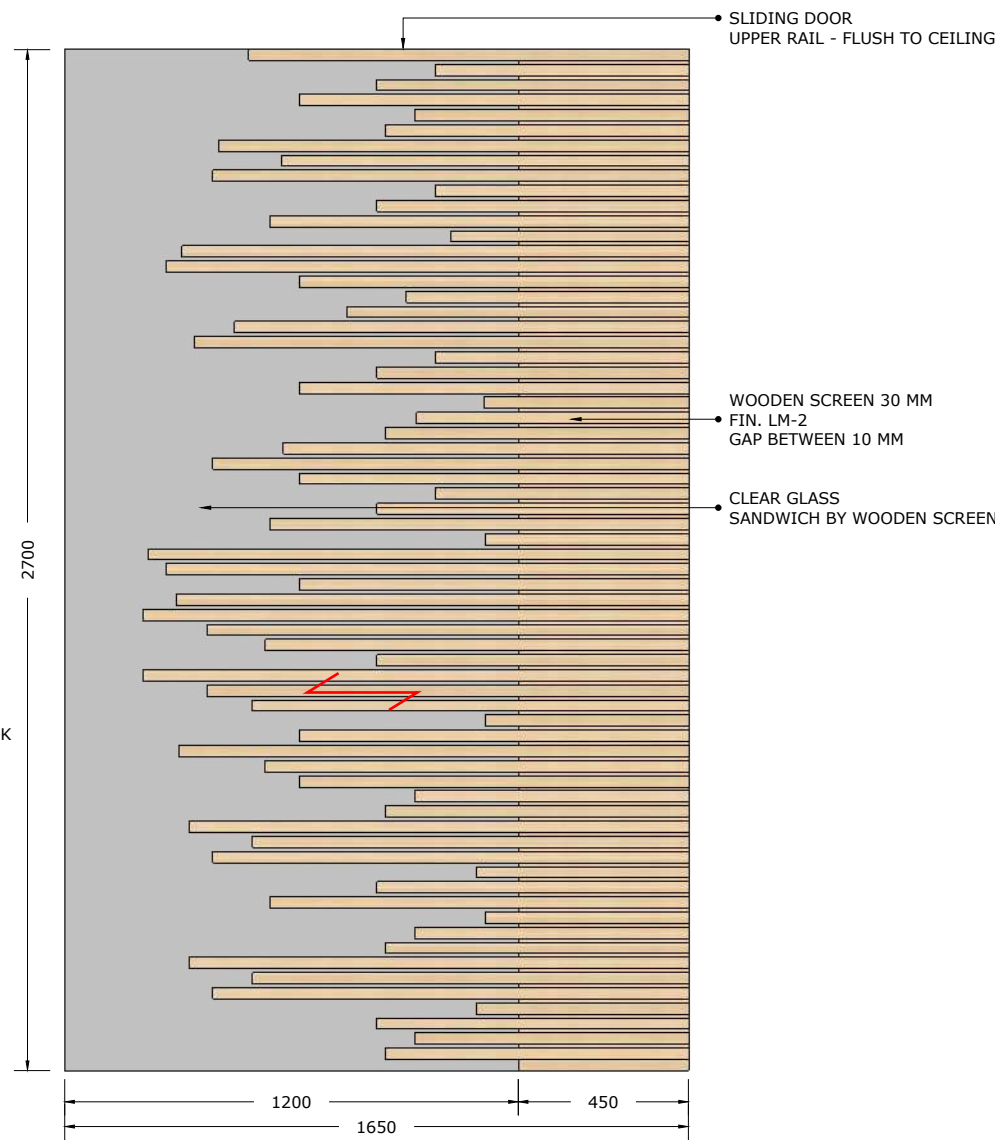

07 FRONT VIEW D4
INT-141 Scale: 1:20

- NOTE :
- SPC-1 : SPC FLOOR, PATINA, LEMON
SPC-2 : PATINA, SKIRTING 80
- CP-1 : SMJ CARPET, BLUESTONE, TIMELESS GREY 50 X 50 CM
CP-2 : SMJ CARPET, CONCEPT LOOP, BLUE SCREEN 50 X 50 CM
CP-3 : SMJ CARPET, COLOR BOX, YELLOW LEMON 50 X 50 CM
CP-4 : VOXFLO, PRISM 01, HEXAGONS 50x43,3 CM
CP-5 : VOXFLO, PRISM 33, HEXAGONS 50x43,3 CM
CP-6 : VOXFLO, CRYSTAL 04 HEXAGONS 50x43,3 CM
CP-7 : VOXFLO, CRYSTAL 10 HEXAGONS 50x43,3 CM
- MT-1 : STAINLESS STEEL HAIRLINE H 80 MM
MT-2 : POWDER COATING METAL, BLACK, DOFF
MT-3 : POWDER COATING METAL, WHITE, DOFF
- PT-1 : PAINT, DULUX XXX
- SP-1 : SPRAY PAINT (DUCCO) YELLOW
SP-2 : SPRAY PAINT (DUCCO) BLUE
SP-3 : SPRAY PAINT (DUCCO) TOSCA
- FB-1 : FABRIC, ATEJA LORENZIA, FESTUS 160
FB-2 : FABRIC, ATEJA LORENZIA, COLOR MATCH TO LM-4
FB-3 : FABRIC, VANIA, FORTE
- GL-1 : CLEAR GLASS
- BG-1 : BACKPAINTED GLASS, HIMALAYA ABADI - GLASSTONE - SUPER WHITE
- LM-1 : HPL, AICA AS-14062CS83 LIGHTGRAY LEGER STONE
LM-2 : HPL, CARTA CT 7878 T ARGENTINA CHERRY
LM-3 : HPL, TACO TH 006 AA MIDNIGHT GREY
LM-4 : HPL, TACO TH 021 AA CANARY YELLOW
- SF-1 : STICKER PRINTING, DOFF
SF-2 : ACRYLIC LASER CU FIN. IN SPRAY PAINT, DOFF
SF-3 : GRADATION STICKER ONE SIDE - WHITE
SF-4 : STICKER FILM GREY 40%

Bintaro Business Centre Building
Jl. RC Veteran No. 1-1 Bintaro
Phone: +62 21 7357679
Fax: +62 21 7433946
www.dezanstudio.com
admin@dezanstudio.com

CLIENT

UNDP

PROJECT

2019 - UNDP PROJECT 3A

DRAWING TITLE

D-3 MAIN DOOR
D-4 SLIDING DOOR

DRAWING No.	REVISION
INT-141	REV A
SCALE 1:20 @A3	CHECKED AS
DATE November 5, 2020	DRAWN AS