


STATE OF PALESTINE

NABLUS SPECIALIZED COURT

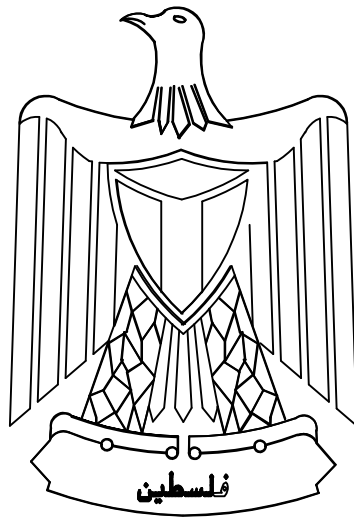

ARCHITECTURAL DRAWINGS

SAFFARINI & ASSOCIATES

Ramallah

Fax 02-2959363

Tel 02-2987675

June, 2021

ARCHITECTURAL			ELECTRICAL		MECHANIC	
GENERAL			E-000	LIST OF DRAWINGS, LEGEND & NOTES	M000	Mechanical Symbols & Legend
A00	LIST OF DRAWINGS		LIGHTING SYSTEM:			
A01	PARKING FLOOR EXISTING PLAN	E-101	PARKING FLOOR LIGHTING SYSTEM		M101	Parking Floor Sanitary System Layout Plan
A02	GROUND FLOOR EXISTING PLAN					
A03	FIRST FLOOR EXISTING PLAN	E-102	GROUND FLOOR LIGHTING SYSTEM		M102	First Floor Sanitary System Layout Plan
A04	SECOND FLOOR EXISTING PLAN	E-103	FIRST FLOOR LIGHTING SYSTEM		M103	Second Floor Sanitary System Layout Plan
A05	PARKING FLOOR DEMOLITION PLAN					
A06	GROUND FLOOR DEMOLITION PLAN	E-104	SECOND FLOOR LIGHTING SYSTEM		M201	First Floor Water System Layout Plan
A07	FIRST FLOOR DEMOLITION PLAN	E-201	POWER & UPS SYSTEMS:		M202	Second Floor Water System Layout Plan
A08	SECOND FLOOR DEMOLITION PLAN					
A09	PARKING FLOOR PROPOSED DIMENSION PLAN		PARKING FLOOR POWER & UPS SYSTEMS		M301	Parking Floor Firefighting System Layout Plan
A10	GROUND FLOOR PROPOSED DIMENSION PLAN	E-202	FIRST FLOOR POWER & UPS SYSTEMS			
A11	FIRST FLOOR PROPOSED DIMENSION PLAN	E-203	SECOND FLOOR POWER & UPS SYSTEMS		M302	Ground Floor Firefighting System Layout Plan
A12	SECOND FLOOR PROPOSED DIMENSION PLAN					
A13	PARKING FLOOR FURNITURE PLAN		IT & TELECOMMUNICATION SYSTEMS		M303	First Floor Firefighting System Layout Plan
A14	GROUND FLOOR FURNITURE PLAN	E-301	PARKING FLOOR IT SYSTEMS		M304	Second Floor Firefighting System Layout Plan
A15	FIRST FLOOR FURNITURE PLAN					
A16	SECOND FLOOR FURNITURE PLAN	E-302	FIRST FLOOR IT SYSTEMS		M401	First Floor Air Conditioning System Layout Plan
A17	PARKING FLOOR FALSE CEILING PLAN	E-303	SECOND FLOOR IT SYSTEMS		M402	Second Floor Air Conditioning System Layout Plan
A18	GROUND FLOOR FALSE CEILING PLAN					
A19	FIRST FLOOR FALSE CEILING PLAN		LOW CURRENT SYSTEMS		M501	Parking Floor Ventilation System Layout Plan
A20	SECOND FLOOR FALSE CEILING PLAN	E-401	PARKING FLOOR LOW CURRENT SYSTEMS		M502	First Floor Ventilation System Layout Plan
A21	PARKING FLOOR TAGS & REFERENCES PLAN	E-402	GROUND FLOOR LOW CURRENT SYSTEMS		M503	Second Floor Ventilation System Layout Plan
A22	GROUND FLOOR TAGS & REFERENCES PLAN					
A23	FIRST FLOOR TAGS & REFERENCES PLAN	E-403	FIRST FLOOR LOW CURRENT SYSTEMS			
A24	SECOND FLOOR TAGS & REFERENCES PLAN	E-404	SECOND FLOOR LOW CURRENT SYSTEMS		M601	Mechanical Schedules
A25	PARKING FLOOR TILING & REFERENCES PLAN	E-405	FM200 SYSTEM DETAILS		M701	Mechanical Details 1
A26	Sections					
A27	FURNITURE SCHEDULE	E-406	FM200 RISER & NOTES		M702	Mechanical Details 2

NOTES :

-  Section/elevation number drawing number.
-  Hollow blockwork.
-  Reinforced concrete column/wall .
-  Reinforced concrete jamba & sills .
-  Plain concrete walls.
-  Insulated gypsum board partitions.
-  F.F.L. Finished floor level .
-  F.L.L. Finished lintel level .
-  F.S.L. Finished sill level .
-  S.L. Slab level .
-  S.B.L. Slab bottom level.
-  F.L. Finished level .
-  R Radius

 EXISTING

REVISION	DATE OF REVISION	INITIALS	REVISION DETAILS
----------	------------------	----------	------------------



ESTABLISH A SPECIALIZED COURT
IN NABLUS

PROJECT No. :

ISSUE : TENDER


DRAWING : List Of Drawing

	DRAWN : SAFFARINI STAFF NO. :	APPROVED: SAFFARINI STAFF NO. :	DATE: JUNE, 2021
	CHECKED: SAFFARINI STAFF NO. :	REF:	SCALE: 1/100

SAFFARINI & ASSOCIATES
Ramallah
Fax 02-2959363
Tel 02-2987675

A00

Rev.: 6

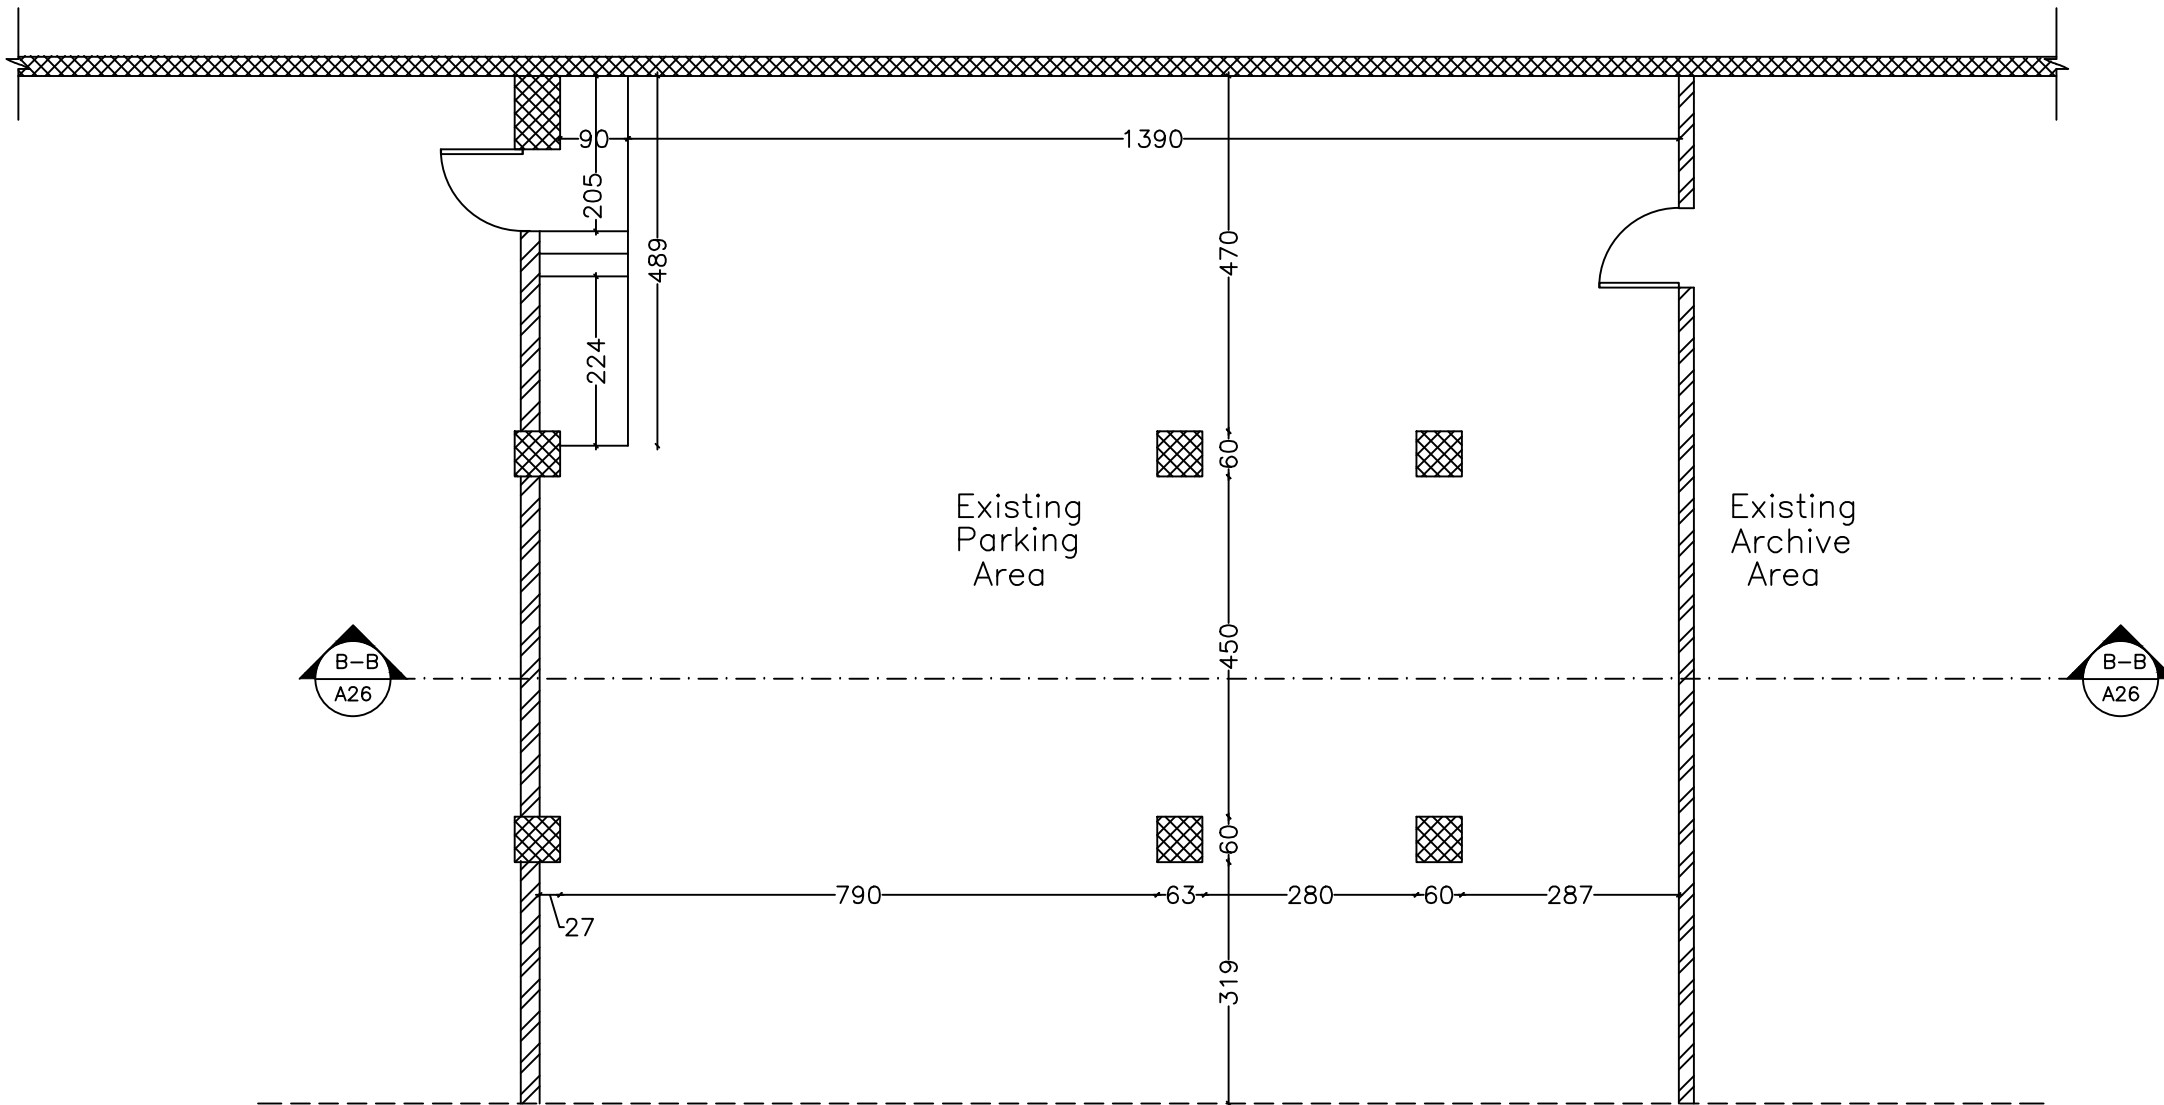

NOTES :

- Section/elevation number drawing number.
- Hollow blockwork.
- Reinforced concrete column/wall .
- Reinforced concrete jambs & sills .
- Plain concrete walls.
- Insulated gypsum board partitions.
- F.F.L Finished floor level .
- F.L.L Finished Lintel Level .
- F.S.L Finished Sill Level .
- S.L Slab level .
- S.B.L Slab bottom level.
- F.L Finished level .
- R Radius

EXISTING

REVISION	DATE OF REVISION	INITIALS	REVISION DETAILS



ESTABLISH A SPECIALIZED COURT
IN NABLUS

PROJECT No. :

ISSUE : TENDER


DRAWING : Existing Parking Floor

	DRAWN : SAFFARINI STAFF NO. : CHECKED: SAFFARINI STAFF NO. :	APPROVED: SAFFARINI STAFF NO. : REF:	DATE: JUNE, 2021 SCALE: 1/100
--	---	--	----------------------------------

SAFFARINI & ASSOCIATES
Ramallah
Fax 02-2959363
Tel 02-2987675

A01

Rev.: 6

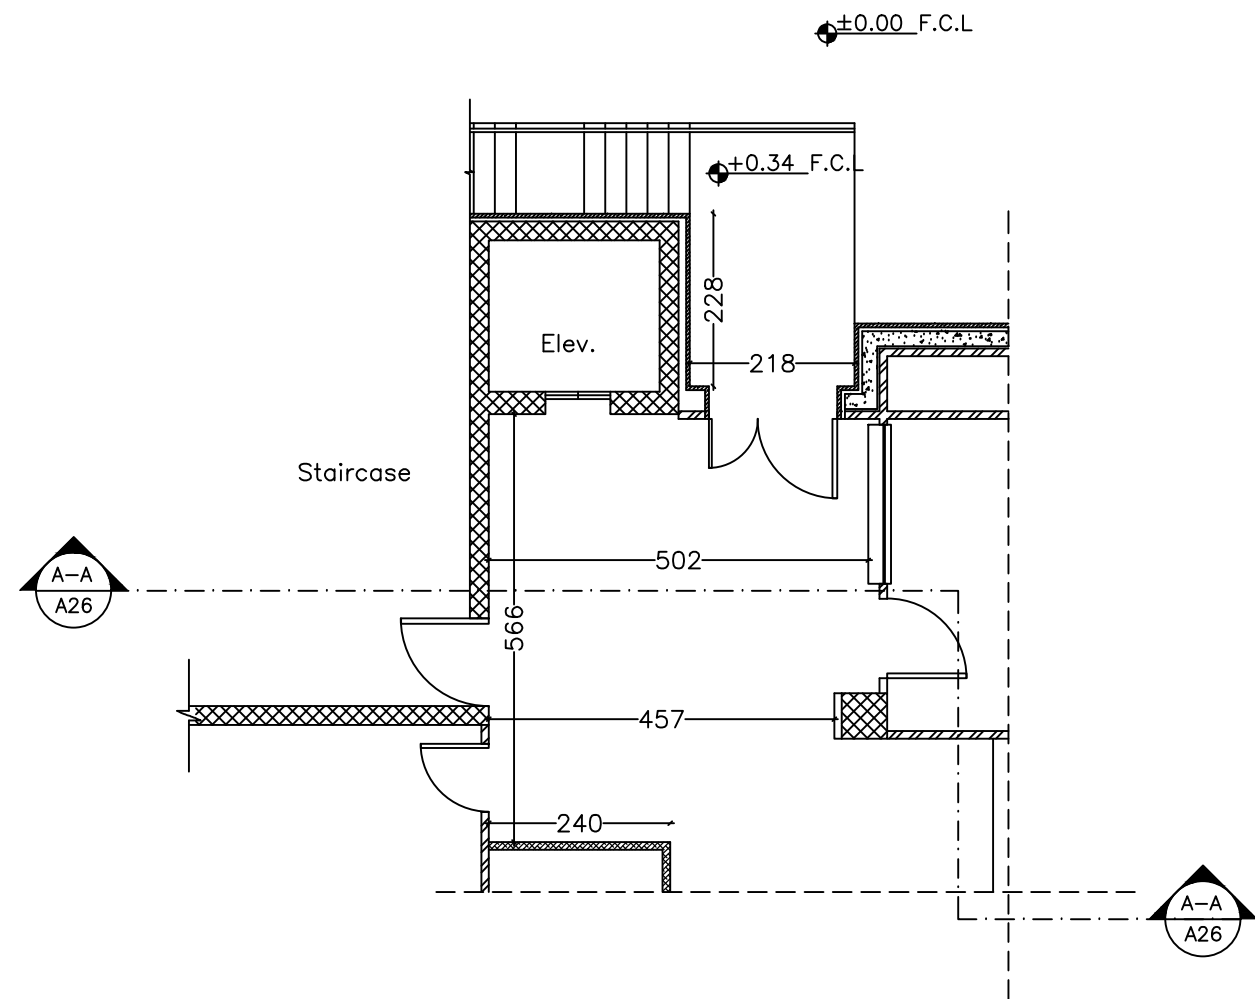

NOTES :

- Section/elevation number drawing number.
- Hollow blockwork.
- Reinforced concrete column/wall .
- Reinforced concrete jambs & sills .
- Plain concrete walls.
- Insulated gypsum board partitions.
- F.F.L. Finished floor level .
- F.L.L. Finished Lintel Level .
- F.S.L. Finished Sill Level .
- S.L. Slab level .
- S.B.L. Slab bottom level.
- F.L. Finished level .
- R Radius

EXISTING

REVISION	DATE OF REVISION	INITIALS	REVISION DETAILS



ESTABLISH A SPECIALIZED COURT
IN NABLUS

PROJECT No. :

ISSUE : TENDER


DRAWING : Existing Ground Floor

	DRAWN : SAFFARINI STAFF NO. : CHECKED: SAFFARINI STAFF NO. :	APPROVED: SAFFARINI STAFF NO. : REF:	DATE: JUNE, 2021 SCALE: 1/100
--	---	--	--------------------------------------

SAFFARINI & ASSOCIATES
Ramallah
Fax 02-2959363
Tel 02-2987675

A02

Rev.: 6

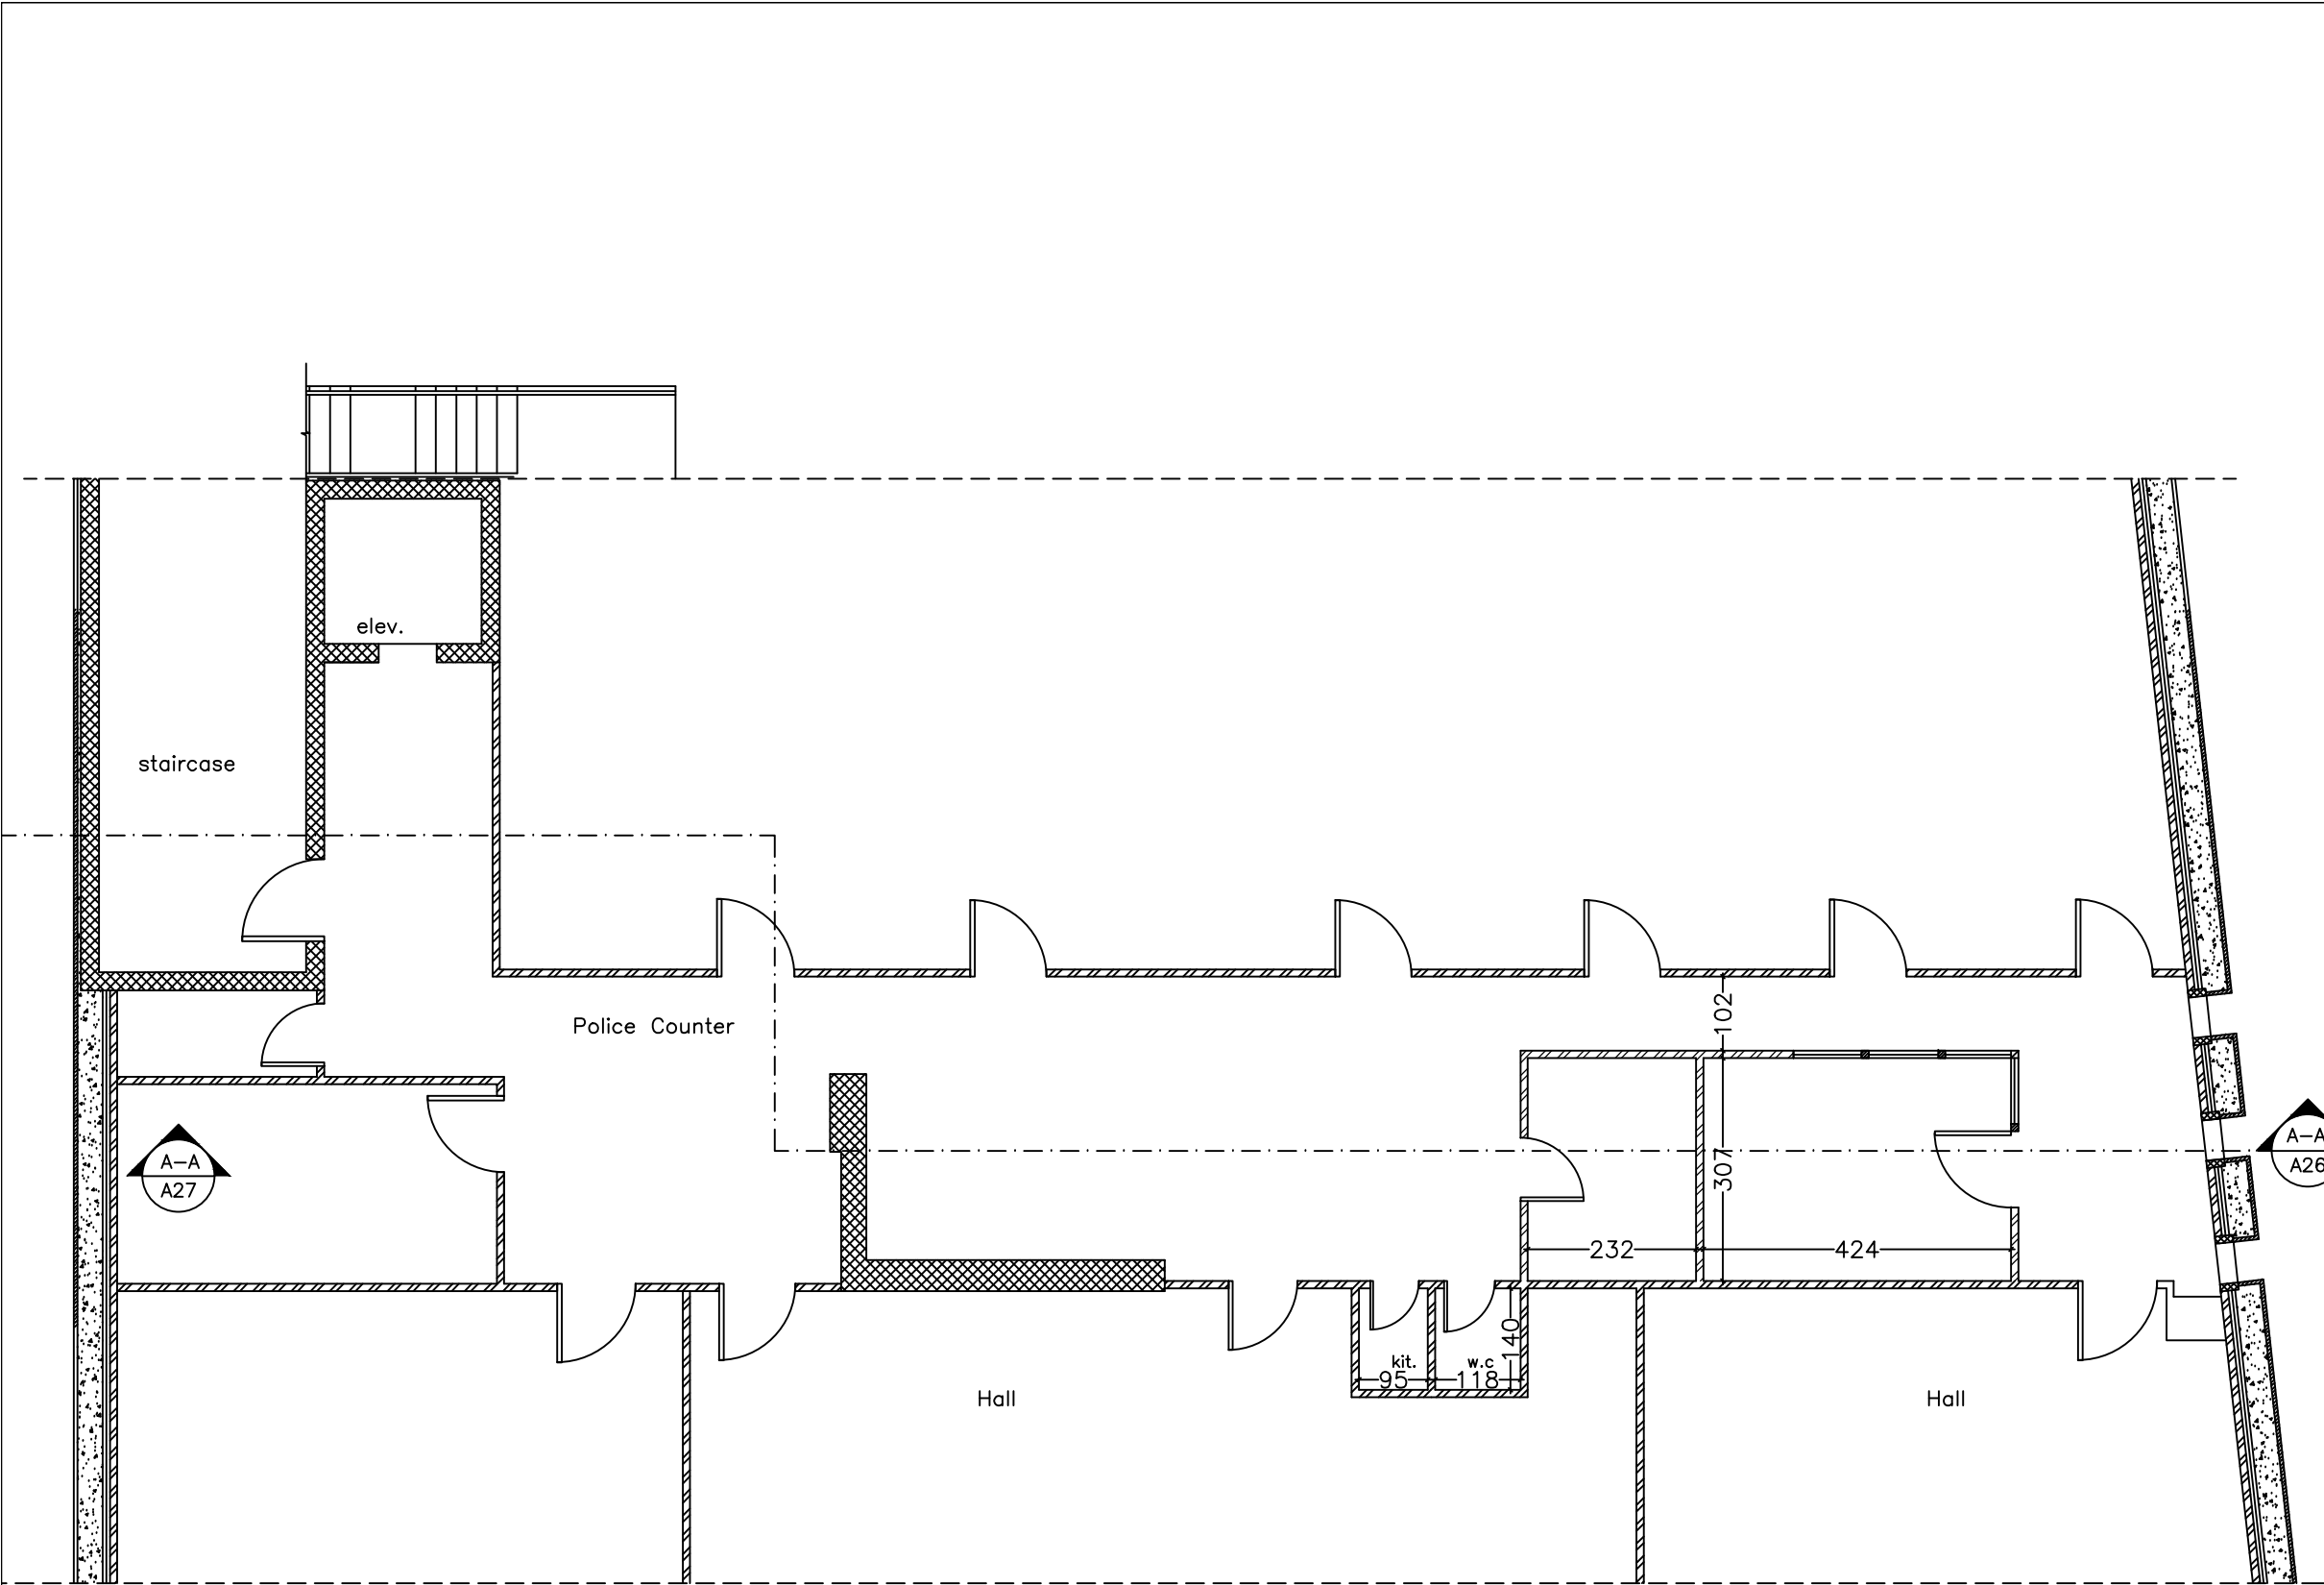

NOTES :

- ⊕ — Section/elevation number drawing number.
- ▨ Hollow blockwork.
- ▤ Reinforced concrete column/wall .
- ▥ Reinforced concrete jambs & sills .
- ▧ Plain concrete walls.
- ▩ Insulated gypsum board partitions.
- ↓ F.F.L Finished floor level .
- ↓ F.L.L Finished Lintel Level .
- ↓ F.S.L Finished Sill Level .
- ↓ S.L Slab level .
- ↓ S.B.L Slab bottom level.
- ↓ F.L Finished level .
- R Radius

▨ EXISTING

REVISION	DATE OF REVISION	INITIALS	REVISION DETAILS



ESTABLISH A SPECIALIZED COURT
IN NABLUS

PROJECT No. :

ISSUE : TENDER


DRAWING : Existing First floor

⊕	DRAWN : SAFFARINI STAFF NO : CHECKED: SAFFARINI STAFF NO :	APPROVED: SAFFARINI STAFF NO. : REF:	DATE: JUNE, 2021 SCALE: 1/100

SAFFARINI & ASSOCIATES
Ramallah
Fax 02-2959363
Tel 02-2987675

A03

Rev.: 6

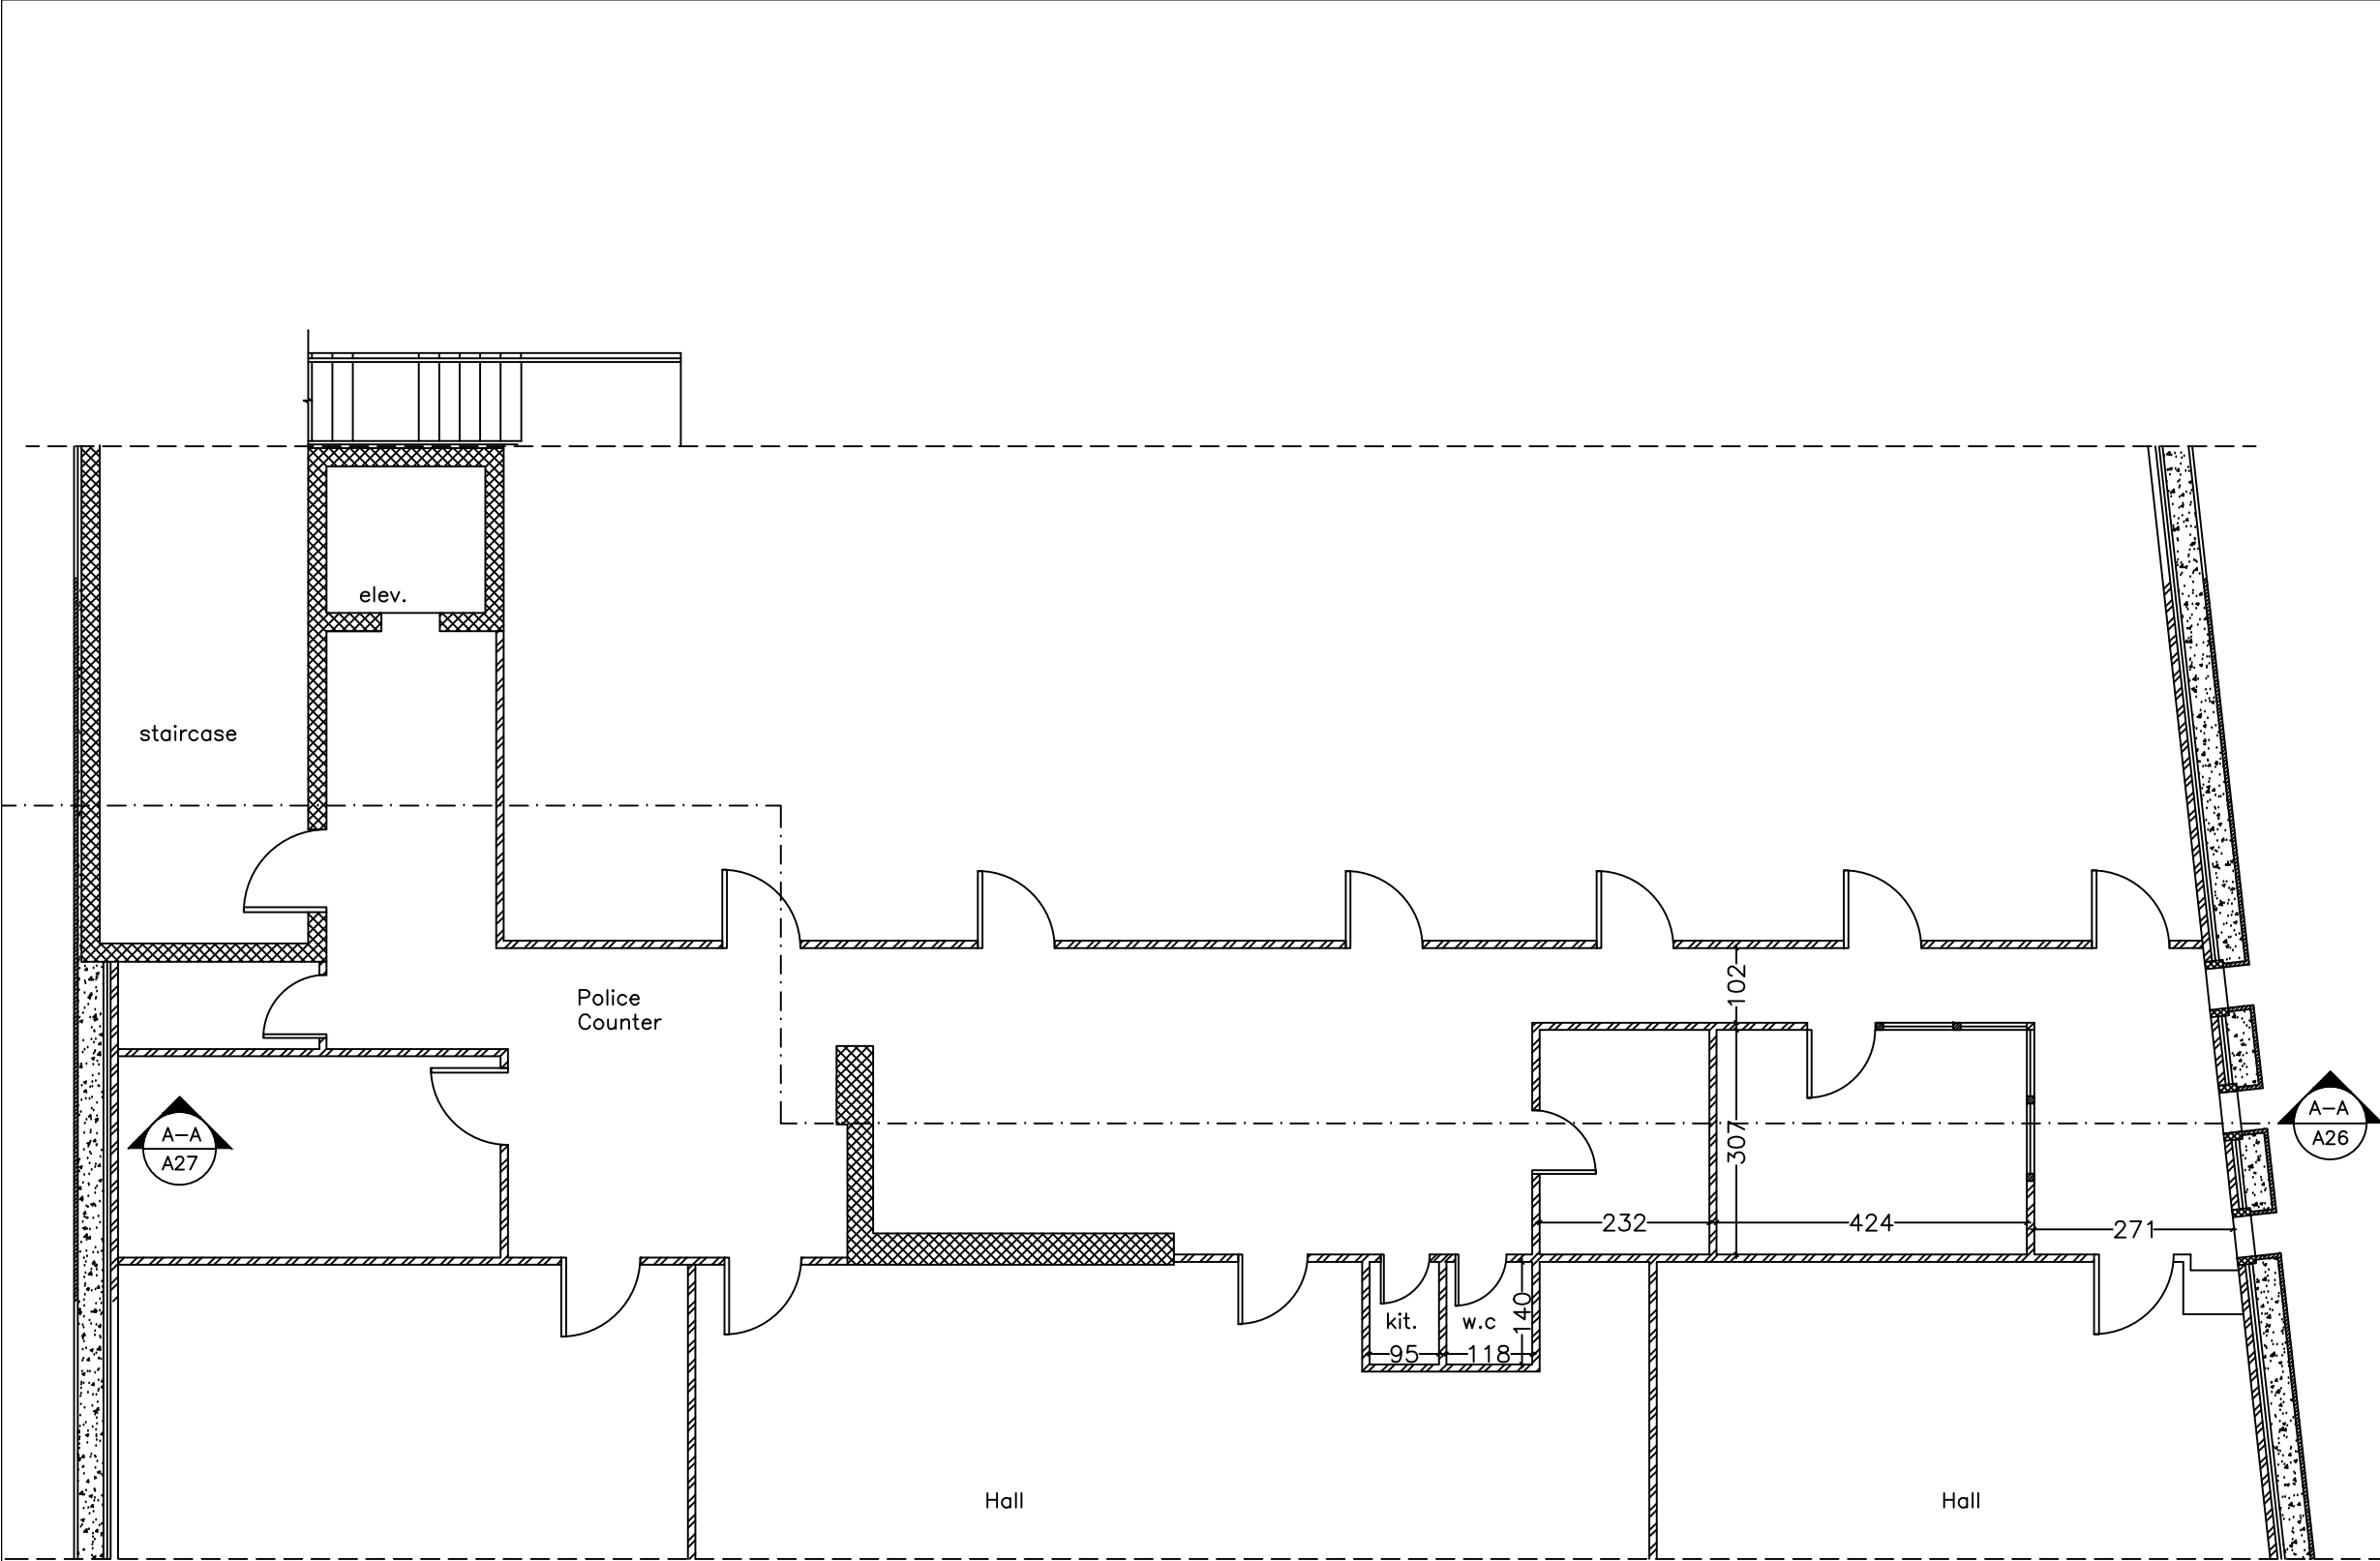

NOTES :

-  Section/elevation number drawing number.
-  Hollow blockwork.
-  Reinforced concrete column/wall .
-  Reinforced concrete jambs & sills .
-  Plain concrete walls.
-  Insulated gypsum board partitions.
-  F.F.L. Finished floor level .
-  F.L.L. Finished lintel level .
-  F.S.L. Finished sill level .
-  S.L. Slab level .
-  S.B.L. Slab bottom level.
-  F.L. Finished level .
-  R Radius

 EXISTING

REVISION	DATE OF REVISION	INITIALS	REVISION DETAILS



ESTABLISH A SPECIALIZED COURT
IN NABLUS

PROJECT No. :

ISSUE : TENDER


DRAWING : Existing Second floor

	DRAWN : SAFFARINI STAFF NO. : CHECKED: SAFFARINI STAFF NO. :	APPROVED: SAFFARINI STAFF NO. : REF:	DATE: JUNE, 2021 SCALE: 1/100
---	---	--	----------------------------------

SAFFARINI & ASSOCIATES
Ramallah
Fax 02-2959363
Tel 02-2987675

A04

Rev.: 6

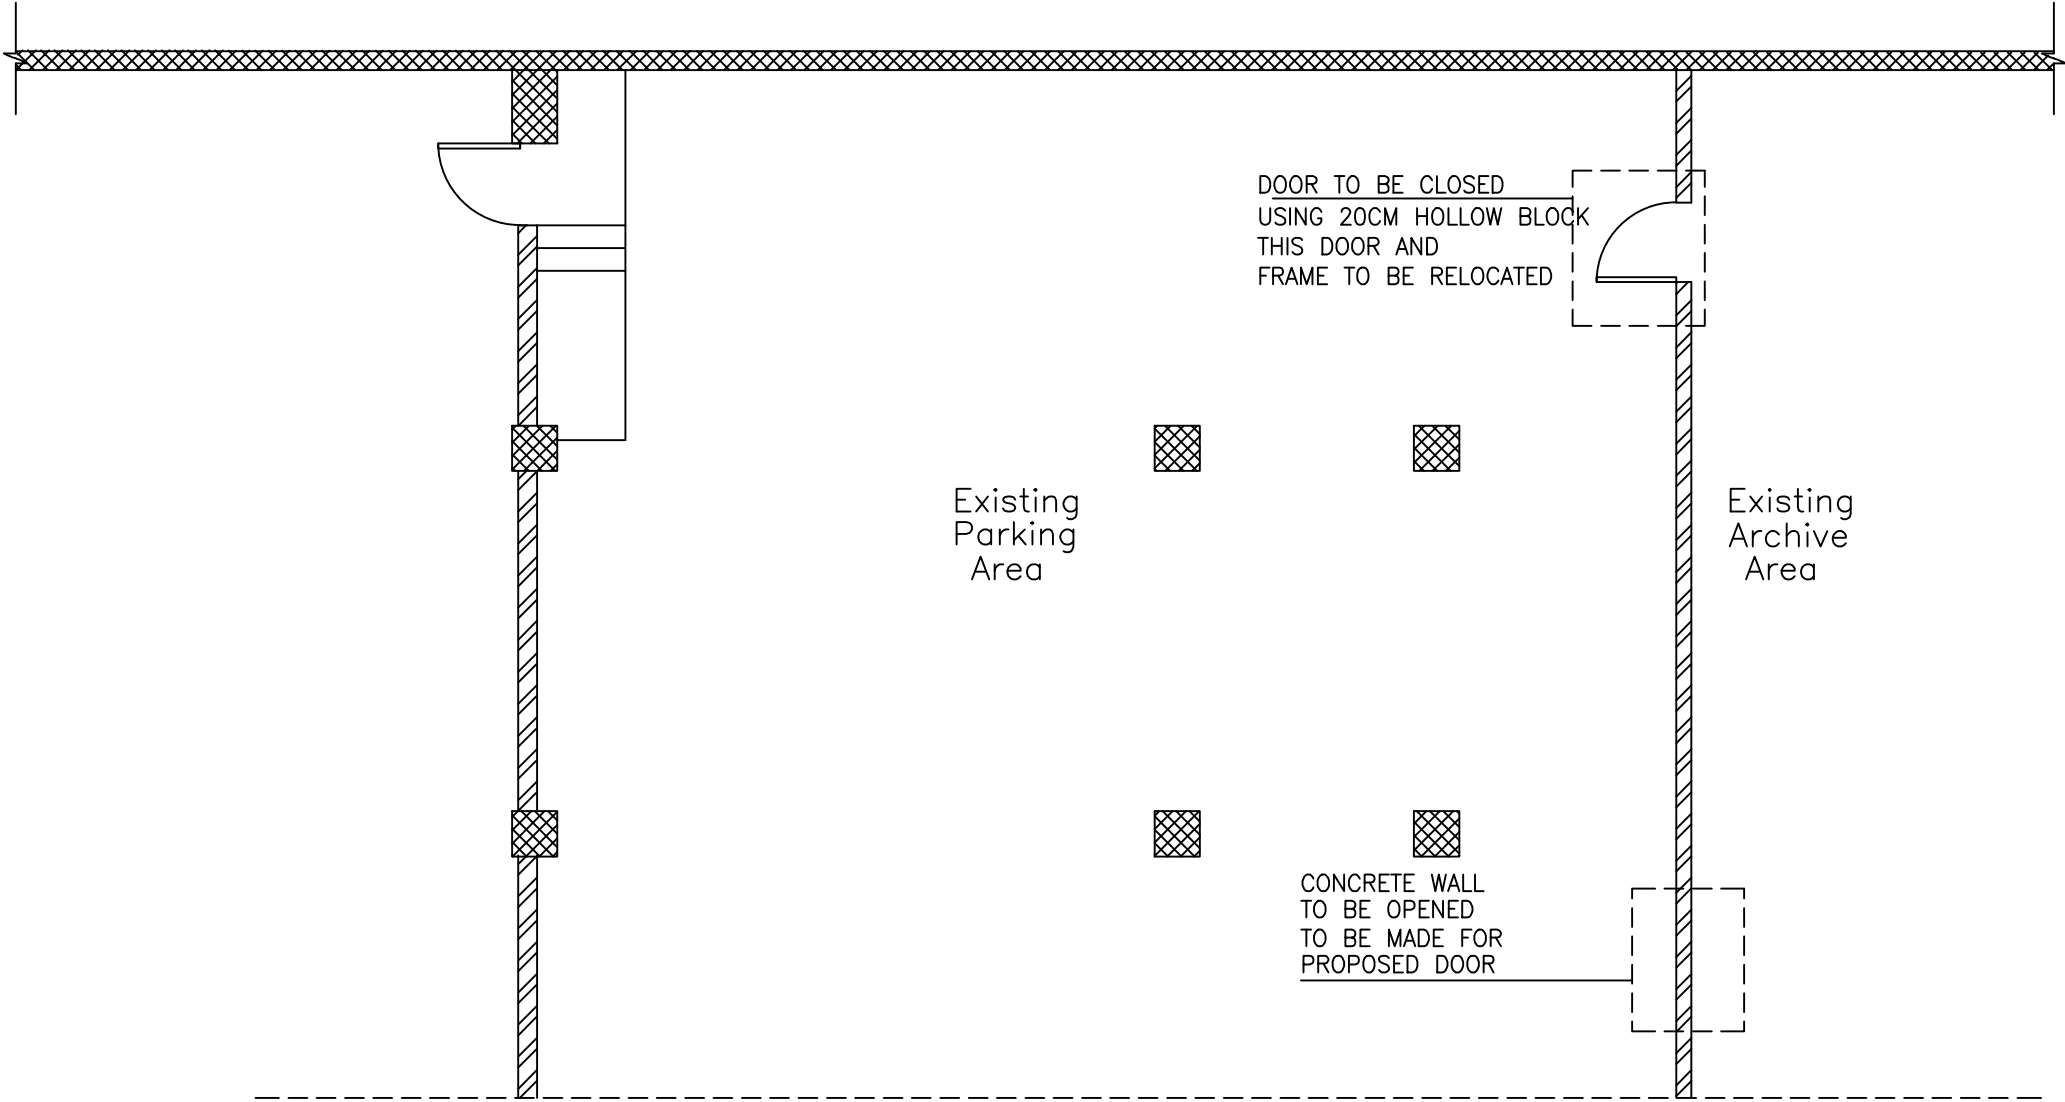

NOTES :

-  Section/elevation number drawing number.
-  Hollow blockwork.
-  Reinforced concrete column/wall .
-  Reinforced concrete jambs & sills .
-  Plain concrete walls.
-  Insulated gypsum board partitions.
-  F.F.L Finished floor level .
-  F.L.L Finished Lintel Level .
-  F.S.L Finished Sill Level .
-  S.L Slab level .
-  S.B.L Slab bottom level.
-  F.L Finished level .
-  R Radius

 EXISTING

REVISION	DATE OF REVISION	INITIALS	REVISION DETAILS
----------	------------------	----------	------------------



ESTABLISH A SPECIALIZED COURT
IN NABLUS


PROJECT No. :
ISSUE : TENDER
DRAWING : Parking Floor Demolition PLAN

	DRAWN : SAFFARINI STAFF NO : CHECKED:SAFFARINI STAFF NO :	APPROVED: SAFFARINI STAFF NO. : REF:	DATE: JUNE, 2021 SCALE: 1/100
---	--	--	----------------------------------

SAFFARINI & ASSOCIATES
Ramallah
Fax 02-2959363
Tel 02-2987675

A05

Rev.: 6

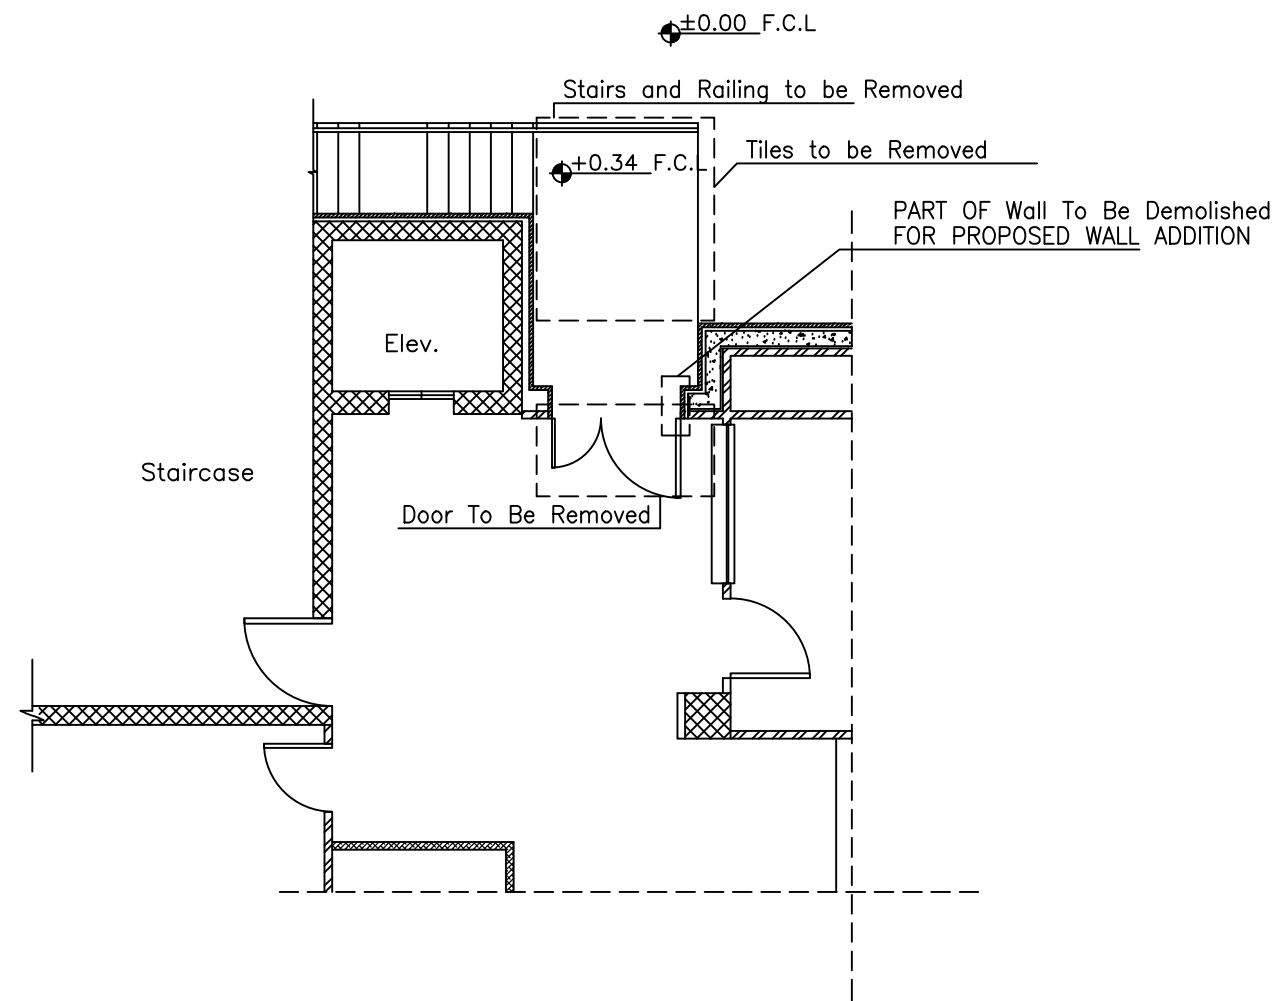

NOTES :

- Section/elevation number drawing number.
- Hollow blockwork.
- Reinforced concrete column/wall .
- Reinforced concrete jambs & sills .
- Plain concrete walls.
- Insulated gypsum board partitions.
- F.F.L Finished floor level .
- F.L.L Finished Lintel Level .
- F.S.L Finished Sill Level .
- S.L Slab level .
- S.B.L Slab bottom level.
- F.L Finished level .
- R Radius

EXISTING

REVISION	DATE OF REVISION	INITIALS	REVISION DETAILS



ESTABLISH A SPECIALIZED COURT
IN NABLUS

PROJECT No. :


ISSUE : TENDER

DRAWING : Ground Floor Demolition PLAN

	DRAWN : SAFFARINI STAFF NO : CHECKED:SAFFARINI STAFF NO :	APPROVED: SAFFARINI STAFF NO. : REF:	DATE: JUNE, 2021 SCALE: 1/100
--	--	--	----------------------------------


SAFFARINI & ASSOCIATES
Ramallah
Fax 02-2959363
Tel 02-2987675

A06
Rev.: 6

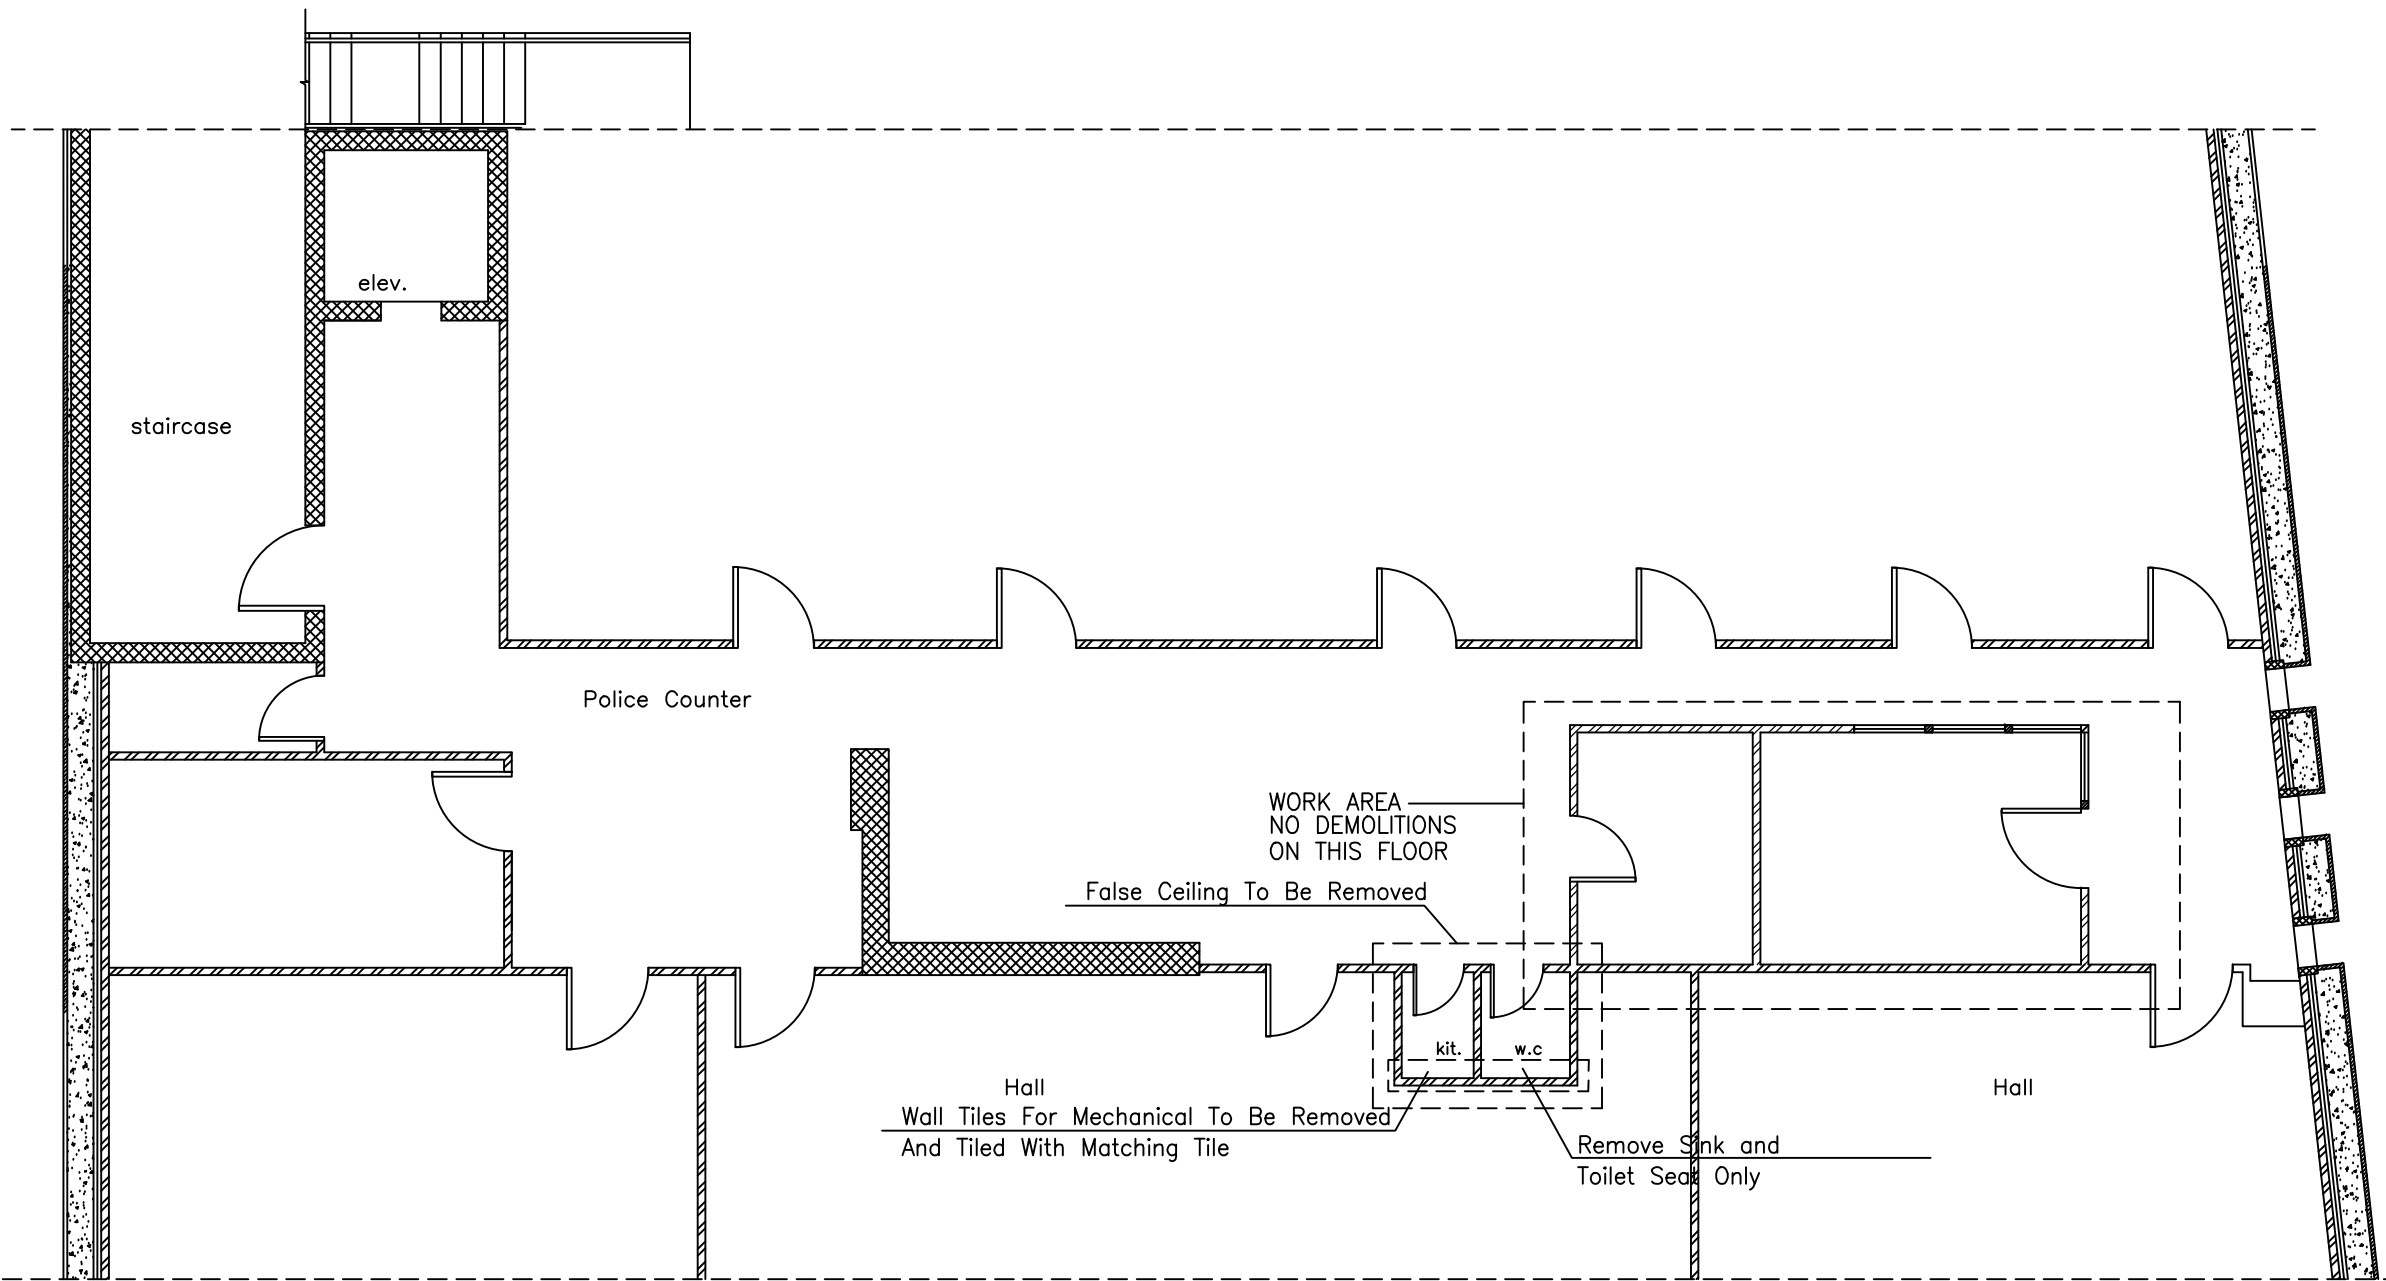

NOTES :

 -  Section/elevation number drawing number.
-  Hollow blockwork.
-  Reinforced concrete column/wall .
-  Reinforced concrete jambs & sills .
-  Plain concrete walls.
-  Insulated gypsum board partitions.
-  F.F.L Finished floor level .
-  F.L.L Finished lintel Level .
-  F.S.L Finished Sill Level .
-  S.L Slab level .
-  S.B.L Slab bottom level.
-  F.L Finished level .
-  R Radius

 EXISTING

REVISION	DATE OF REVISION	INITIALS	REVISION DETAILS




ESTABLISH A SPECIALIZED COURT
IN NABLUS

PROJECT No. :			
ISSUE : TENDER			
DRAWING : Demolition First Floor			
	DRAWN : SAFFARINI STAFF NO : CHECKED: SAFFARINI STAFF NO :	APPROVED: SAFFARINI STAFF NO. : REF:	DATE: JUNE, 2021 SCALE: 1/100

SAFFARINI & ASSOCIATES
Ramallah
Fax 02-2959363
Tel 02-2987675

A07

Rev.: 6

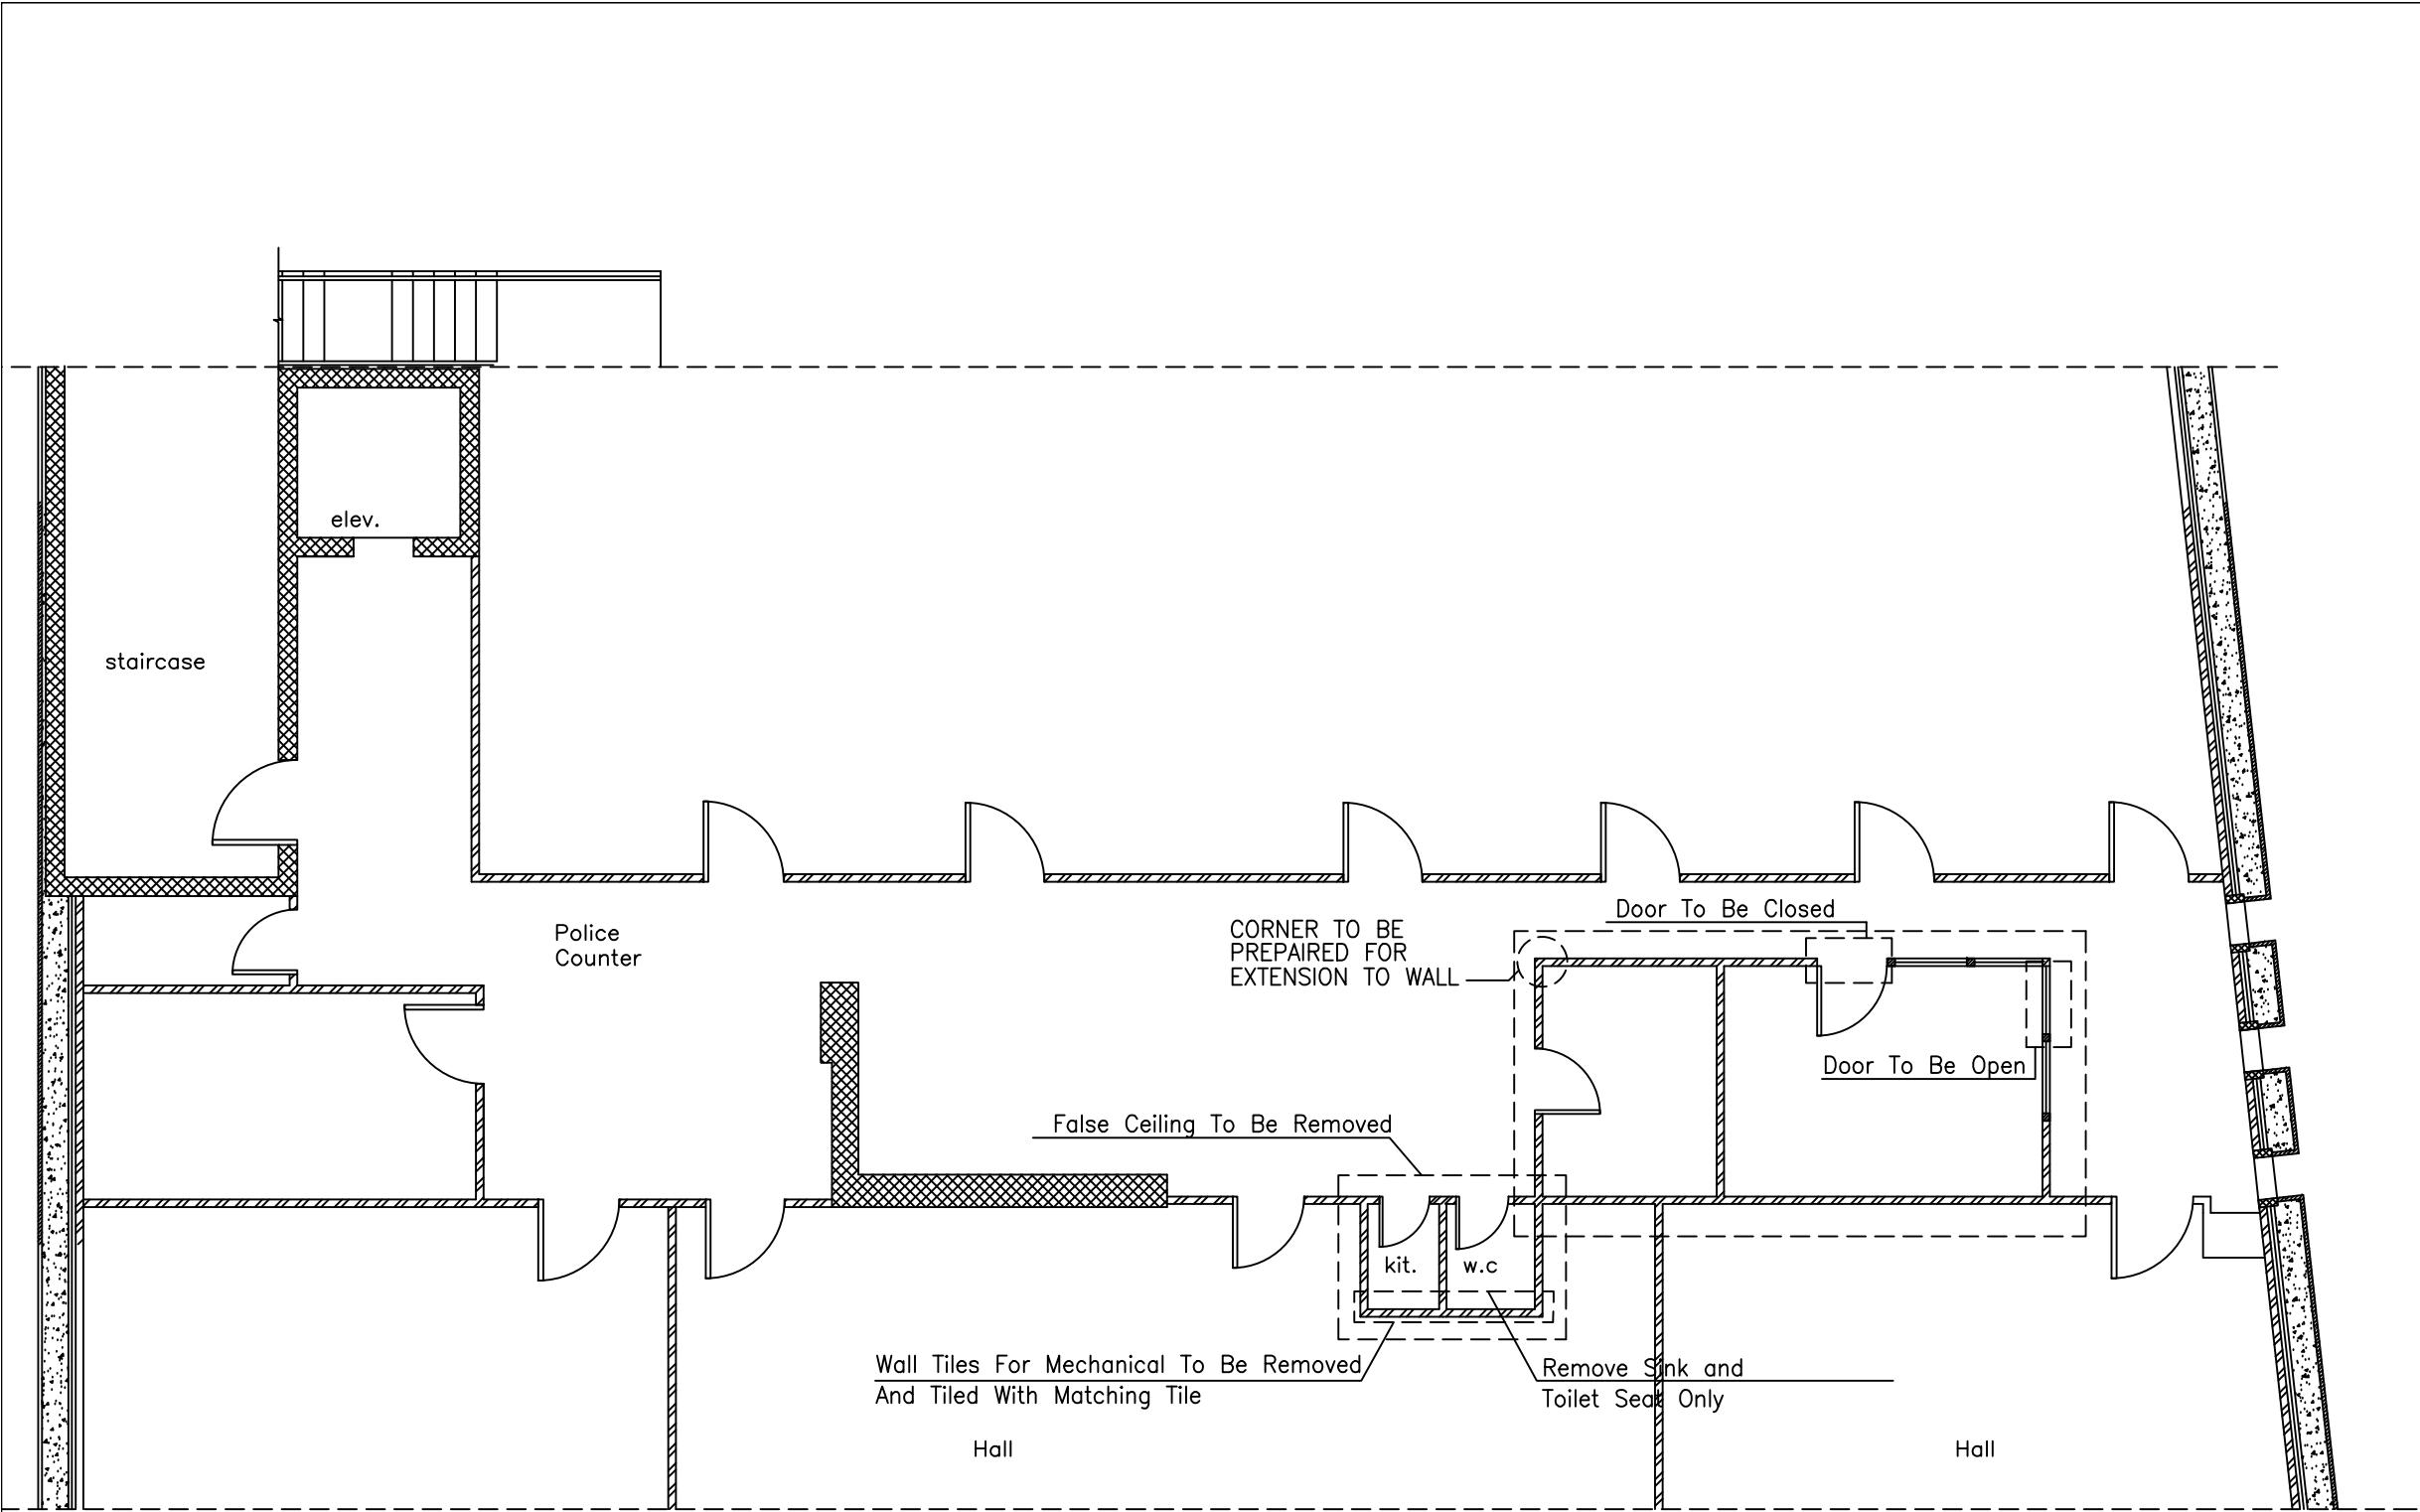

NOTES :

- Section/elevation number drawing number.
- Hollow blockwork.
- Reinforced concrete column/wall .
- Reinforced concrete jambs & sills .
- Plain concrete walls.
- Insulated gypsum board partitions.
- Finished floor level .
- Finished Lintel Level .
- Finished Sill Level .
- Slab level .
- Slab bottom level.
- Finished level .
- Radius

EXISTING

REVISION	DATE OF REVISION	INITIALS	REVISION DETAILS



ESTABLISH A SPECIALIZED COURT
IN NABLUS


PROJECT No. :	
ISSUE : TENDER	
DRAWING : Demolition Second floor	
DRAWN : SAFFARINI STAFF NO : CHECKED: SAFFARINI STAFF NO :	APPROVED: SAFFARINI STAFF NO. : REF:
DATE: JUNE, 2021	SCALE: 1/100

SAFFARINI & ASSOCIATES
Ramallah
Fax 02-2959363
Tel 02-2987675

A08

Rev.: 6

Rev.: 6

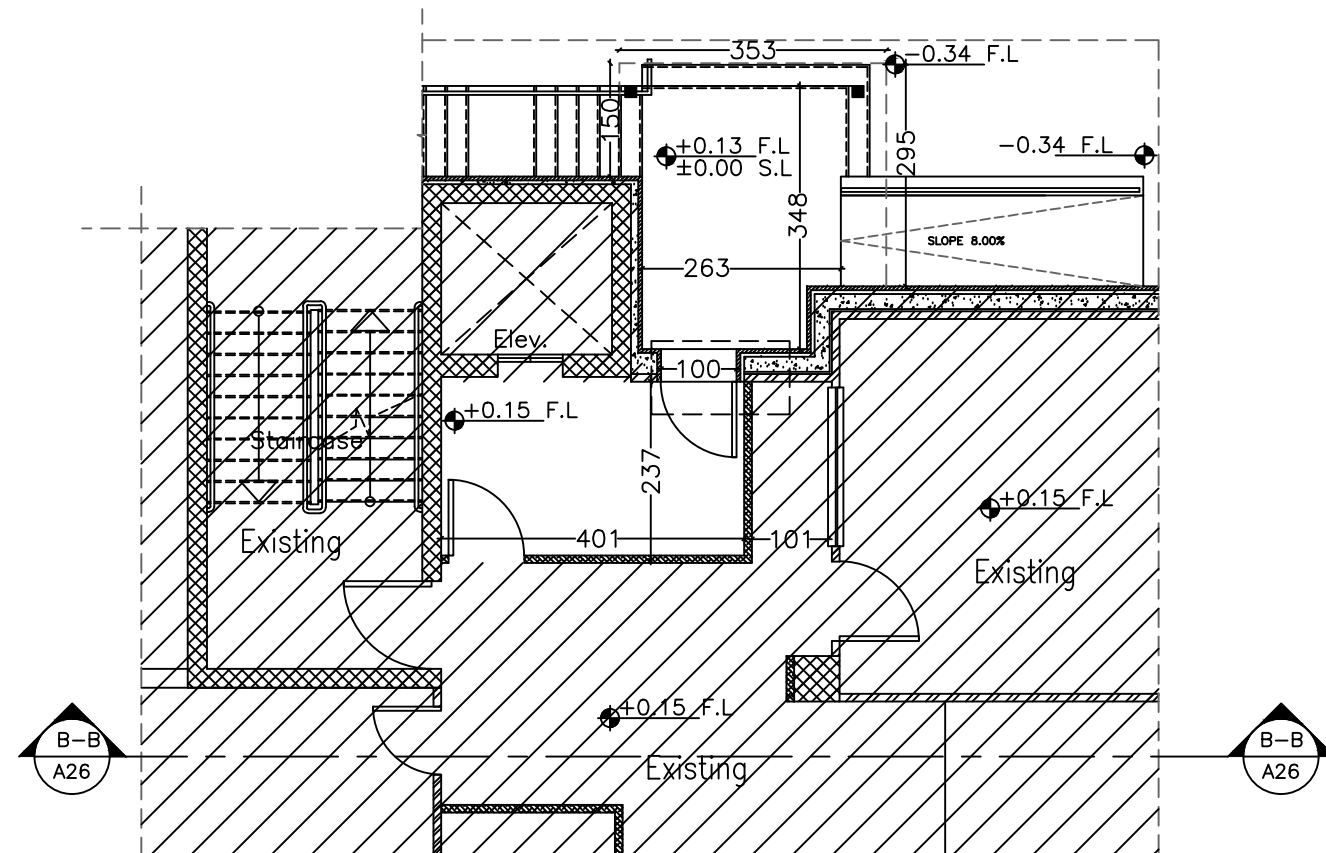

NOTES :

- Section/elevation number drawing number.
- Hollow blockwork.
- Reinforced concrete column/wall .
- Reinforced concrete jambs & sills .
- Plain concrete walls.
- Insulated gypsum board partitions.
- F.F.L Finished floor level .
- F.L.L Finished Lintel Level .
- F.S.L Finished Sill Level .
- S.L Slab level .
- S.B.L Slab bottom level.
- F.L Finished level .
- R Radius

EXISTING

REVISION	DATE OF REVISION	INITIALS	REVISION DETAILS



ESTABLISH A SPECIALIZED COURT
IN NABLUS

PROJECT No. :

ISSUE : TENDER


DRAWING : Dimensions Proposed
Ground Floor

	DRAWN : SAFFARINI STAFF NO : CHECKED: SAFFARINI STAFF NO :	APPROVED: SAFFARINI STAFF NO. : REF:	DATE: JUNE, 2021 SCALE: 1/100
--	---	--	----------------------------------

SAFFARINI & ASSOCIATES
Ramallah
Fax 02-2959363
Tel 02-2987675

A10

Rev.: 6

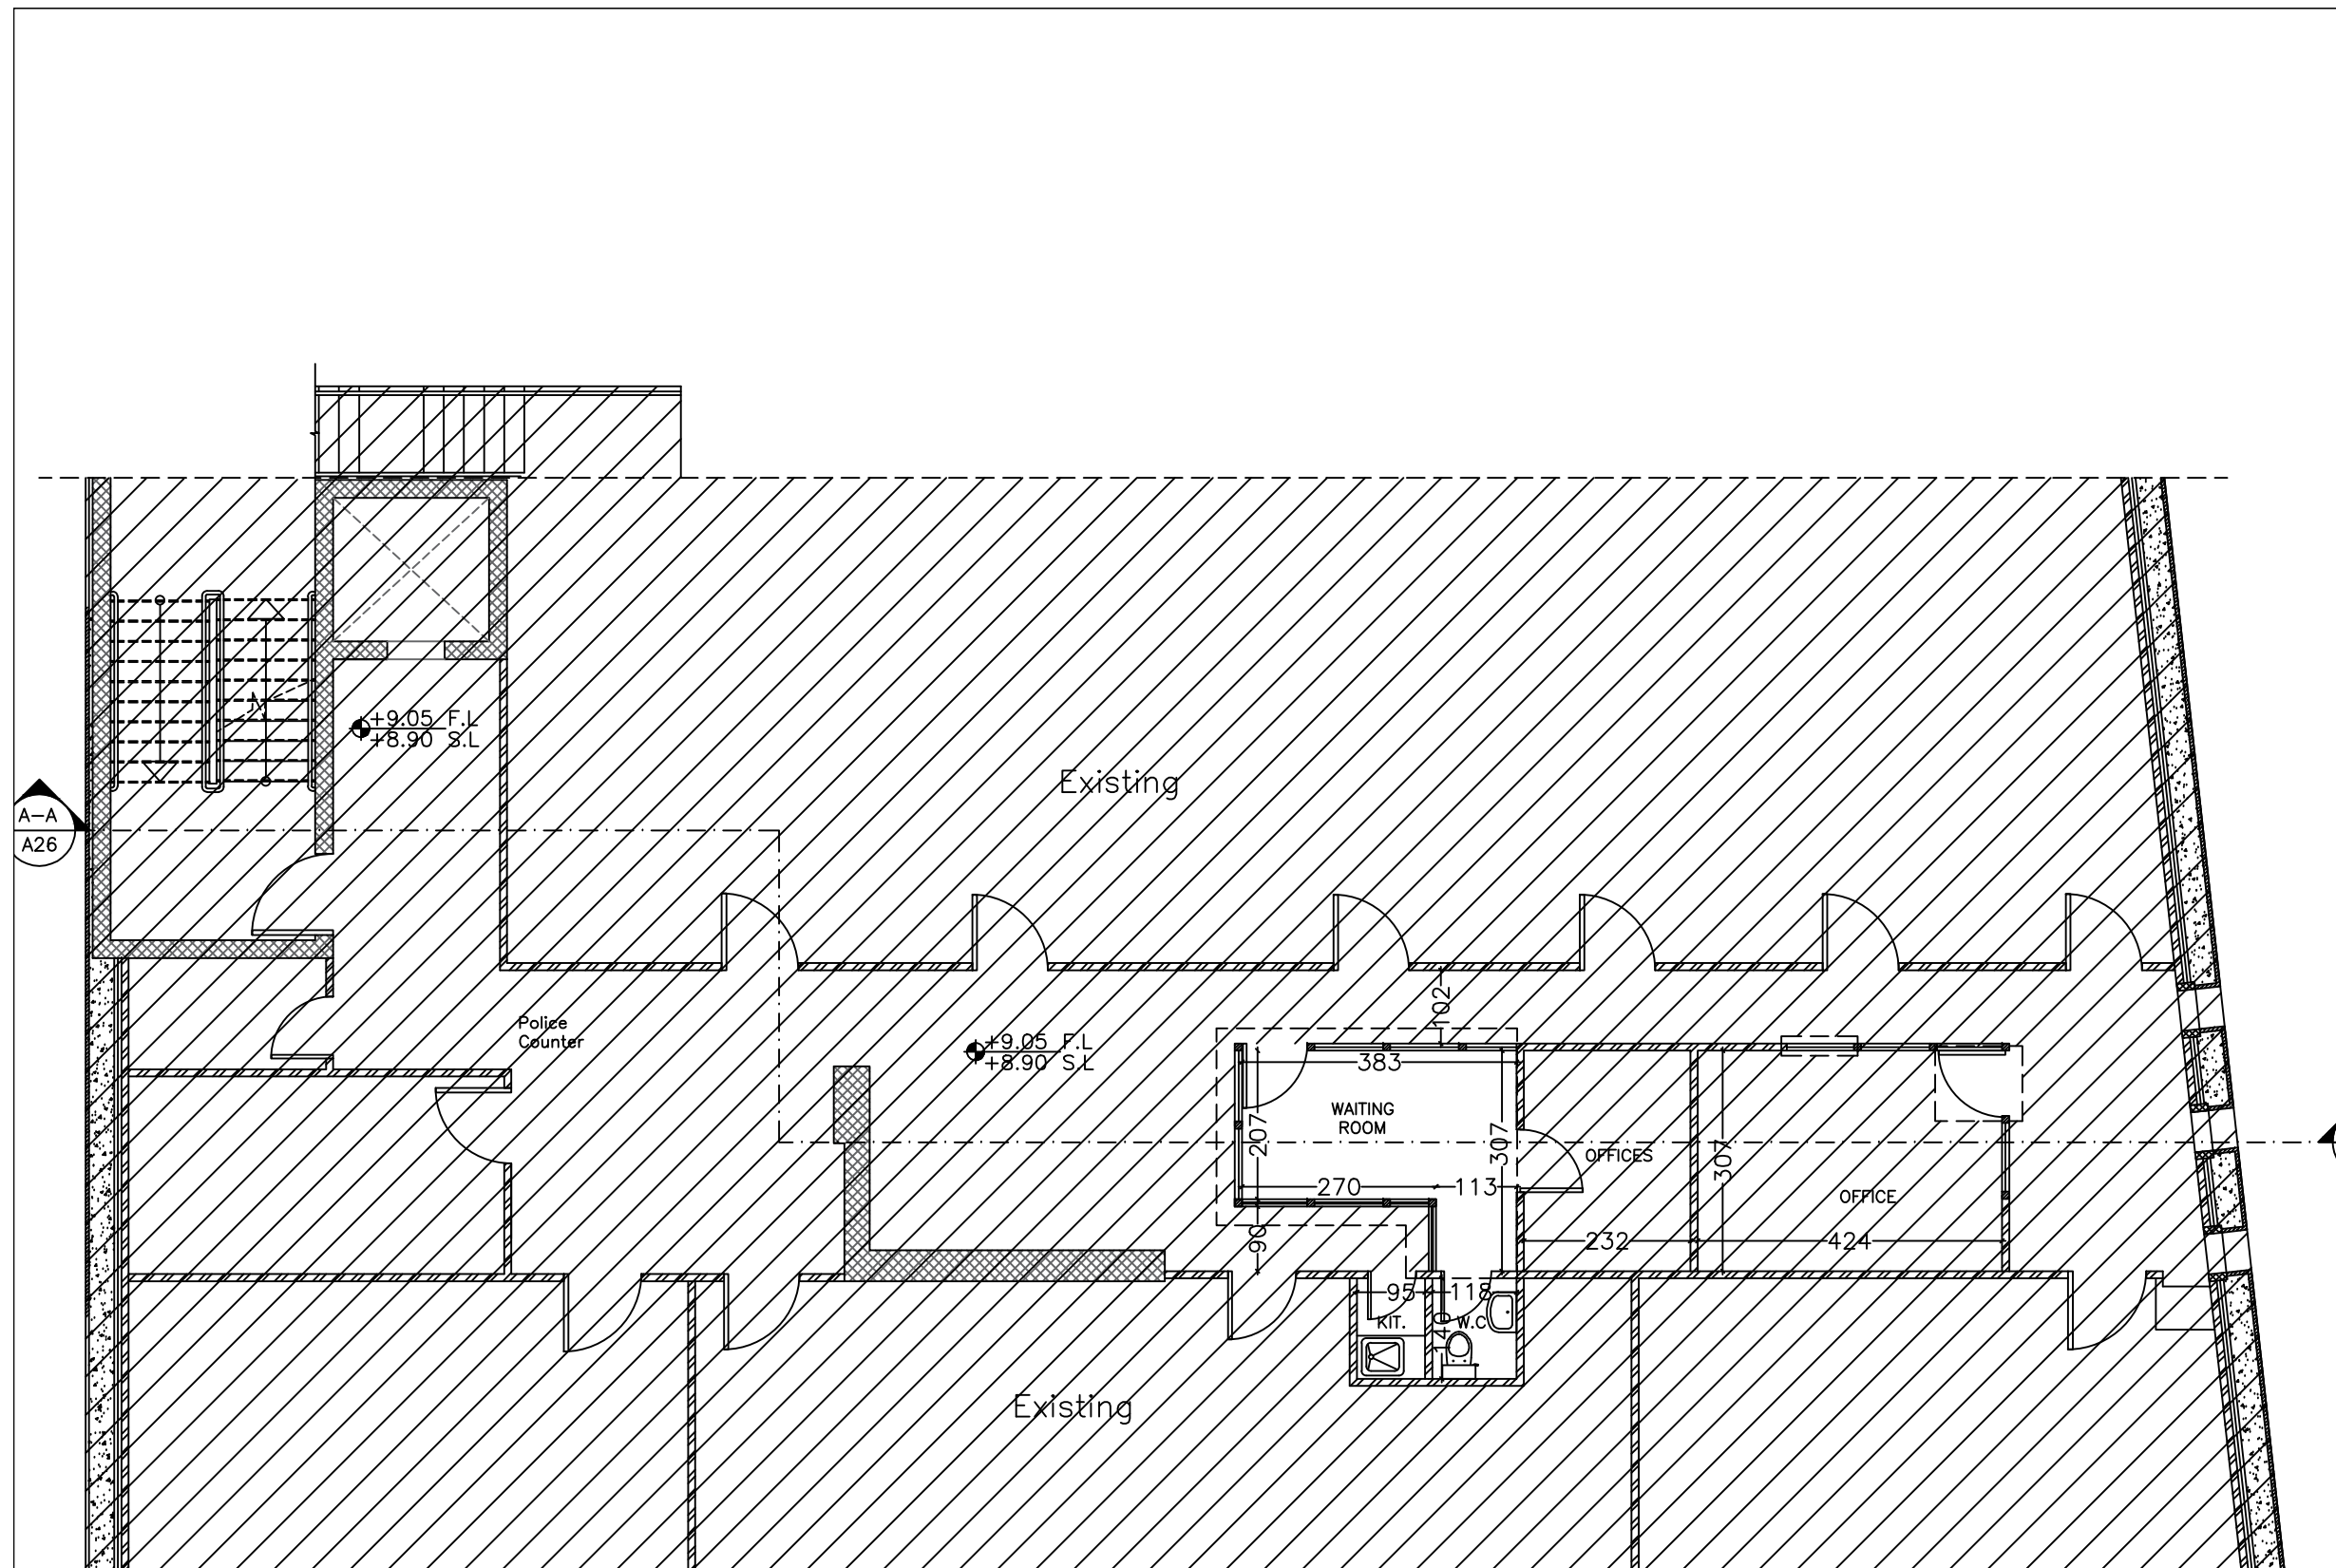

NOTES :

- Section/elevation number drawing number.
- Hollow blockwork.
- Reinforced concrete column/wall .
- Reinforced concrete jambs & sills .
- Plain concrete walls.
- Insulated gypsum board partitions.
- F.F.L Finished floor level .
- F.L.L Finished Lintel Level .
- F.S.L Finished Sill Level .
- S.L Slab level .
- S.B.L Slab bottom level.
- F.L Finished level .
- R Radius

EXISTING

REVISION	DATE OF REVISION	INITIALS	REVISION DETAILS
----------	------------------	----------	------------------



ESTABLISH A SPECIALIZED COURT
IN NABLUS

PROJECT No. :

ISSUE : TENDER


DRAWING : Dimensions Proposed
Second Floor

	DRAWN : SAFFARINI STAFF NO : CHECKED: SAFFARINI STAFF NO :	APPROVED: SAFFARINI STAFF NO : REF:	DATE: JUNE, 2021 SCALE: 1/100
--	---	---	----------------------------------

SAFFARINI & ASSOCIATES
Ramallah
Fax 02-2959363
Tel 02-2987675

A12

Rev.: 6

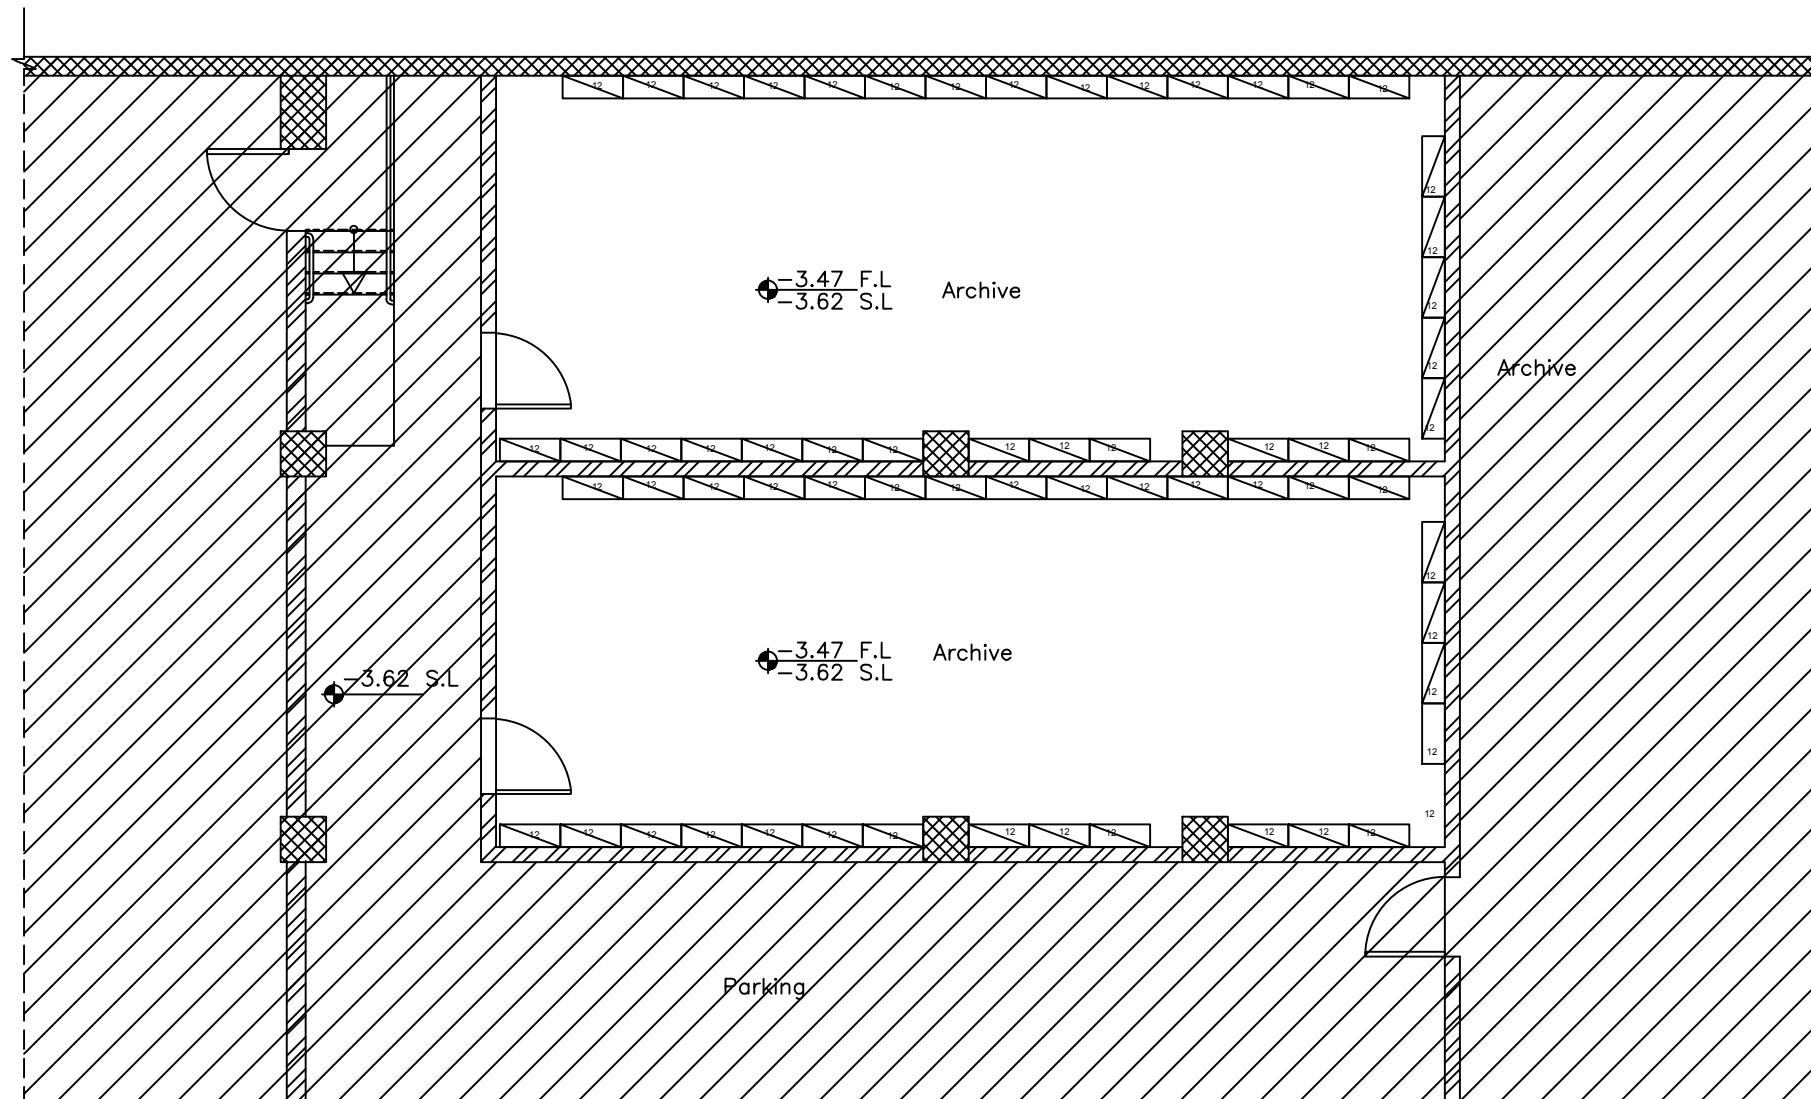

NOTES :

- Section/elevation number drawing number.
- Hollow blockwork.
- Reinforced concrete column/wall .
- Reinforced concrete jambs & sills .
- Plain concrete walls.
- Insulated gypsum board partitions.
- F.F.L Finished floor level .
- F.L.L Finished Lintel Level .
- F.S.L Finished Sill Level .
- S.L Slab level .
- S.B.L Slab bottom level.
- F.L Finished level .
- R Radius

EXISTING

REVISION	DATE OF REVISION	INITIALS	REVISION DETAILS



ESTABLISH A SPECIALIZED COURT
IN NABLUS

PROJECT No. :

ISSUE : TENDER


DRAWING : Parking Floor Furniture Plan

	DRAWN : SAFFARINI STAFF NO : CHECKED: SAFFARINI STAFF NO :	APPROVED: SAFFARINI STAFF NO. : REF:	DATE: JUNE, 2021 SCALE: 1/100
--	---	--	----------------------------------

SAFFARINI & ASSOCIATES
Ramallah
Fax 02-2959363
Tel 02-2987675

A13

Rev.: 6

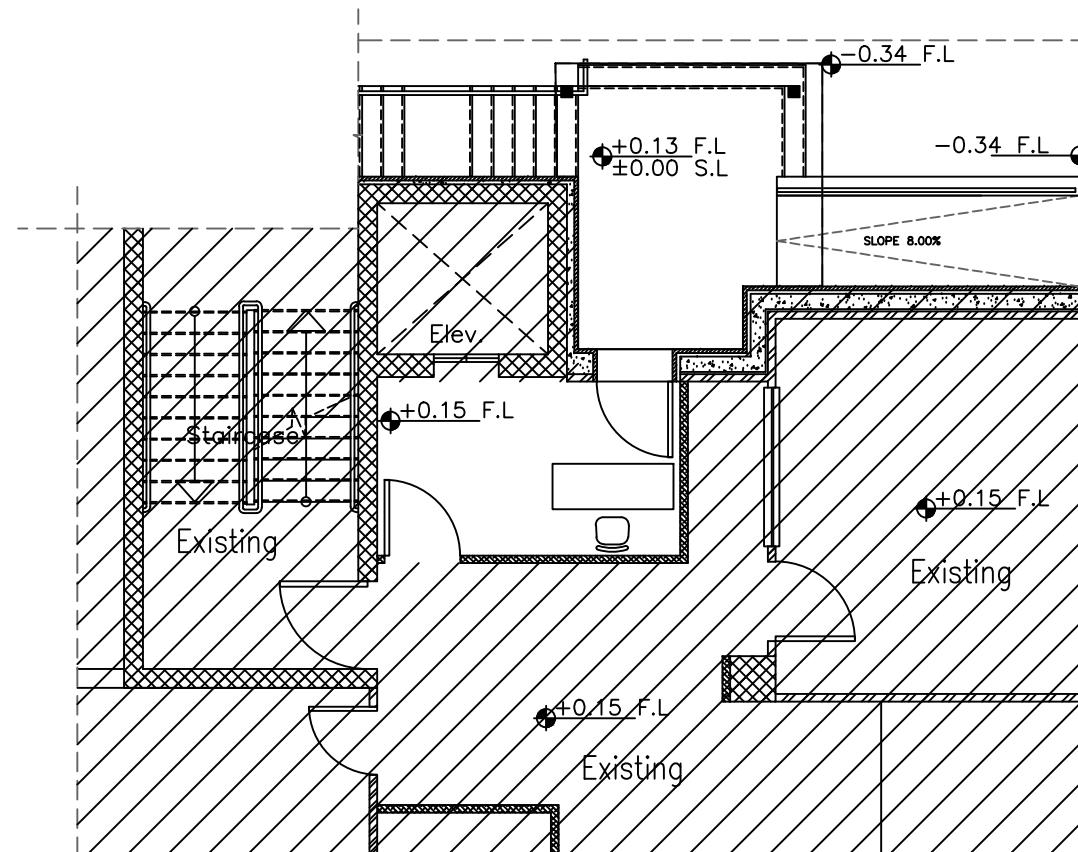

NOTES :

- Section/elevation number drawing number.
- Hollow blockwork.
- Reinforced concrete column/wall .
- Reinforced concrete jambs & sills .
- Plain concrete walls.
- Insulated gypsum board partitions.
- F.F.L Finished floor level .
- F.L.L Finished Lintel Level .
- F.S.L Finished Sill Level .
- S.L Slab level .
- S.B.L Slab bottom level.
- F.L Finished level .
- R Radius

EXISTING

REVISION	DATE OF REVISION	INITIALS	REVISION DETAILS



ESTABLISH A SPECIALIZED COURT
IN NABLUS

PROJECT No. :

ISSUE : TENDER


DRAWING : Ground Floor Furniture Plan

	DRAWN : SAFFARINI STAFF NO. : CHECKED: SAFFARINI STAFF NO. :	APPROVED: SAFFARINI STAFF NO. : REF:	DATE: JUNE, 2021 SCALE: 1/100
--	---	--	----------------------------------

SAFFARINI & ASSOCIATES
Ramallah
Fax 02-2959363
Tel 02-2987675

A14

Rev.: 6

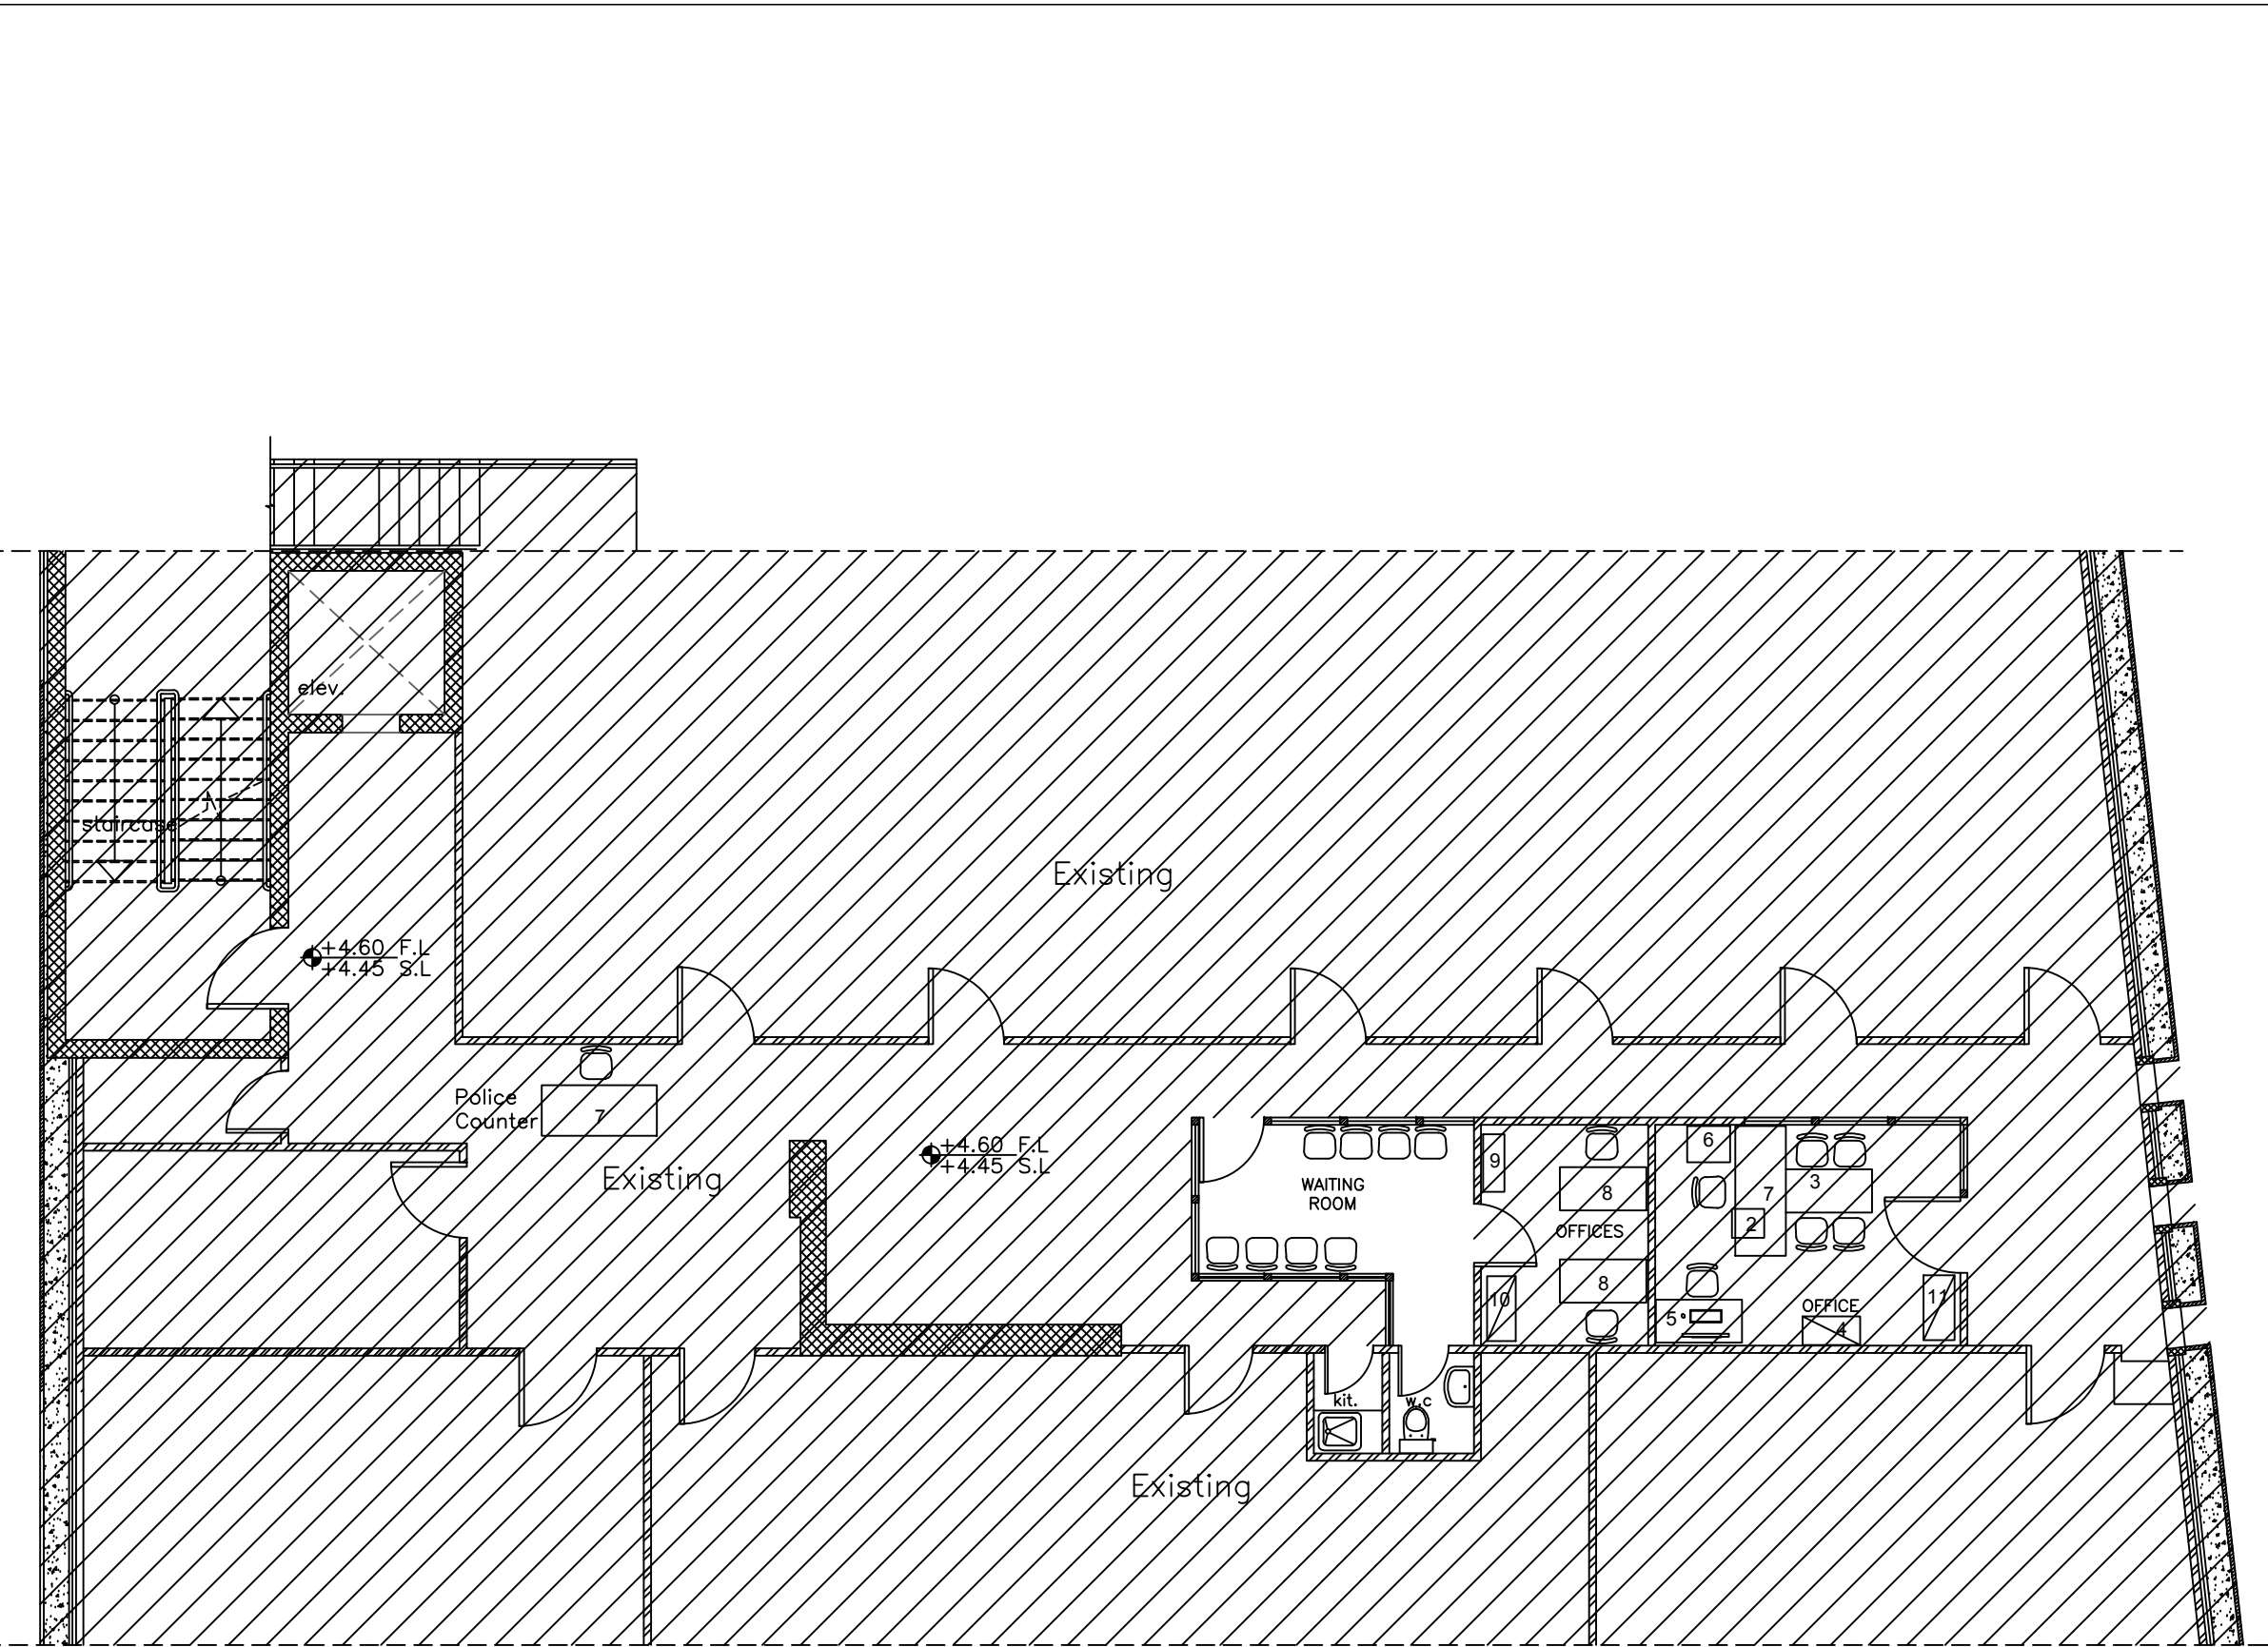

NOTES :

-  Section/elevation number drawing number.
-  Hollow blockwork.
-  Reinforced concrete column/wall .
-  Reinforced concrete jambs & sills .
-  Plain concrete walls.
-  Insulated gypsum board partitions.
-  F.F.L. Finished floor level .
-  F.L.L. Finished lintel level .
-  F.S.L. Finished sill level .
-  S.L. Slab level .
-  S.B.L. Slab bottom level.
-  F.L. Finished level .
-  R Radius

 EXISTING

REVISION	DATE OF REVISION	INITIALS	REVISION DETAILS
----------	------------------	----------	------------------



ESTABLISH A SPECIALIZED COURT
IN NABLUS

PROJECT No. :

ISSUE : TENDER


DRAWING : First Floor Furniture Plan

	DRAWN : SAFFARINI STAFF NO. : CHECKED: SAFFARINI STAFF NO. :	APPROVED: SAFFARINI STAFF NO. : REF:	DATE: JUNE, 2021 SCALE: 1/100
---	---	--	----------------------------------

SAFFARINI & ASSOCIATES
Ramallah
Fax 02-2959363
Tel 02-2987675

A15

Rev.: 6

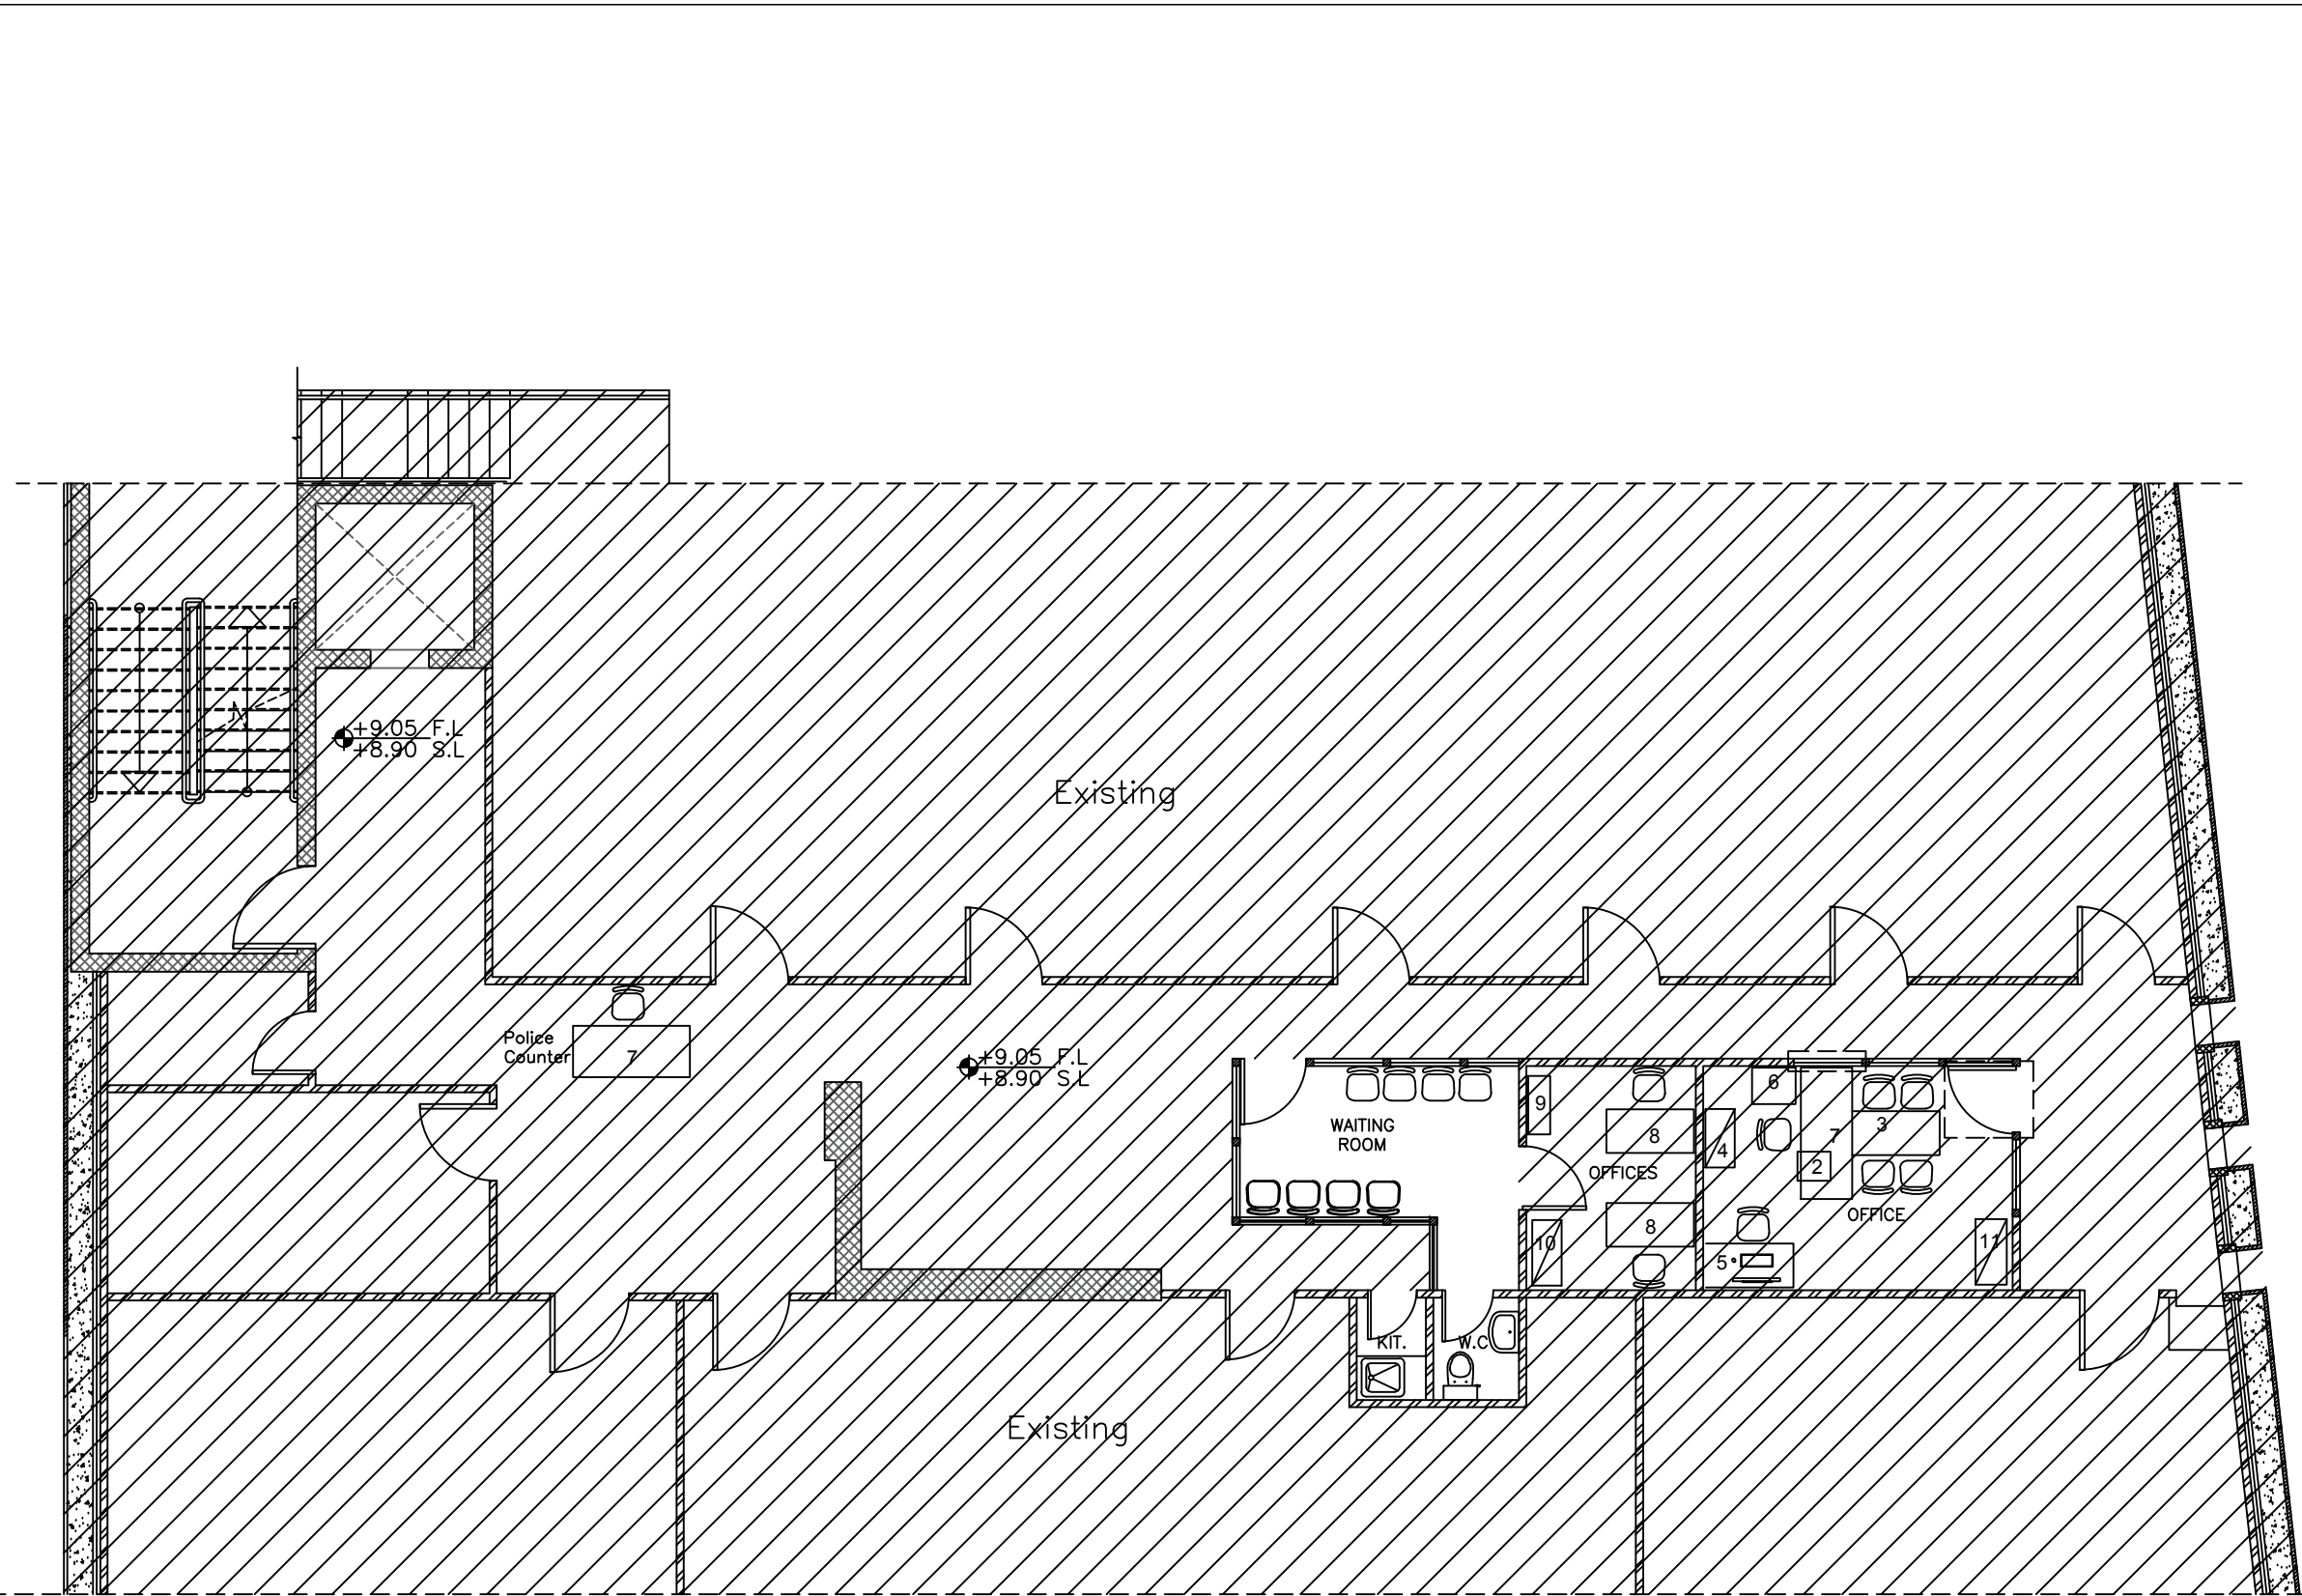

NOTES :

- Section/elevation number drawing number.
- Hollow blockwork.
- Reinforced concrete column/wall .
- Reinforced concrete jambs & sills .
- Plain concrete walls.
- Insulated gypsum board partitions.
- F.F.L. Finished floor level .
- F.L.L. Finished Lintel Level .
- F.S.L. Finished Sill Level .
- S.L. Slab level .
- S.B.L. Slab bottom level.
- F.L. Finished level .
- R Radius

EXISTING

REVISION	DATE OF REVISION	INITIALS	REVISION DETAILS
----------	------------------	----------	------------------



ESTABLISH A SPECIALIZED COURT
IN NABLUS


PROJECT No. :
ISSUE : TENDER
DRAWING : Second floor Furniture Plan

DRAWN : SAFFARINI STAFF NO. : CHECKED: SAFFARINI STAFF NO. :	APPROVED: SAFFARINI STAFF NO. : REF:	DATE: JUNE, 2021
		SCALE: 1/100

SAFFARINI & ASSOCIATES
Ramallah
Fax 02-2959363
Tel 02-2987675

A16

Rev.: 6

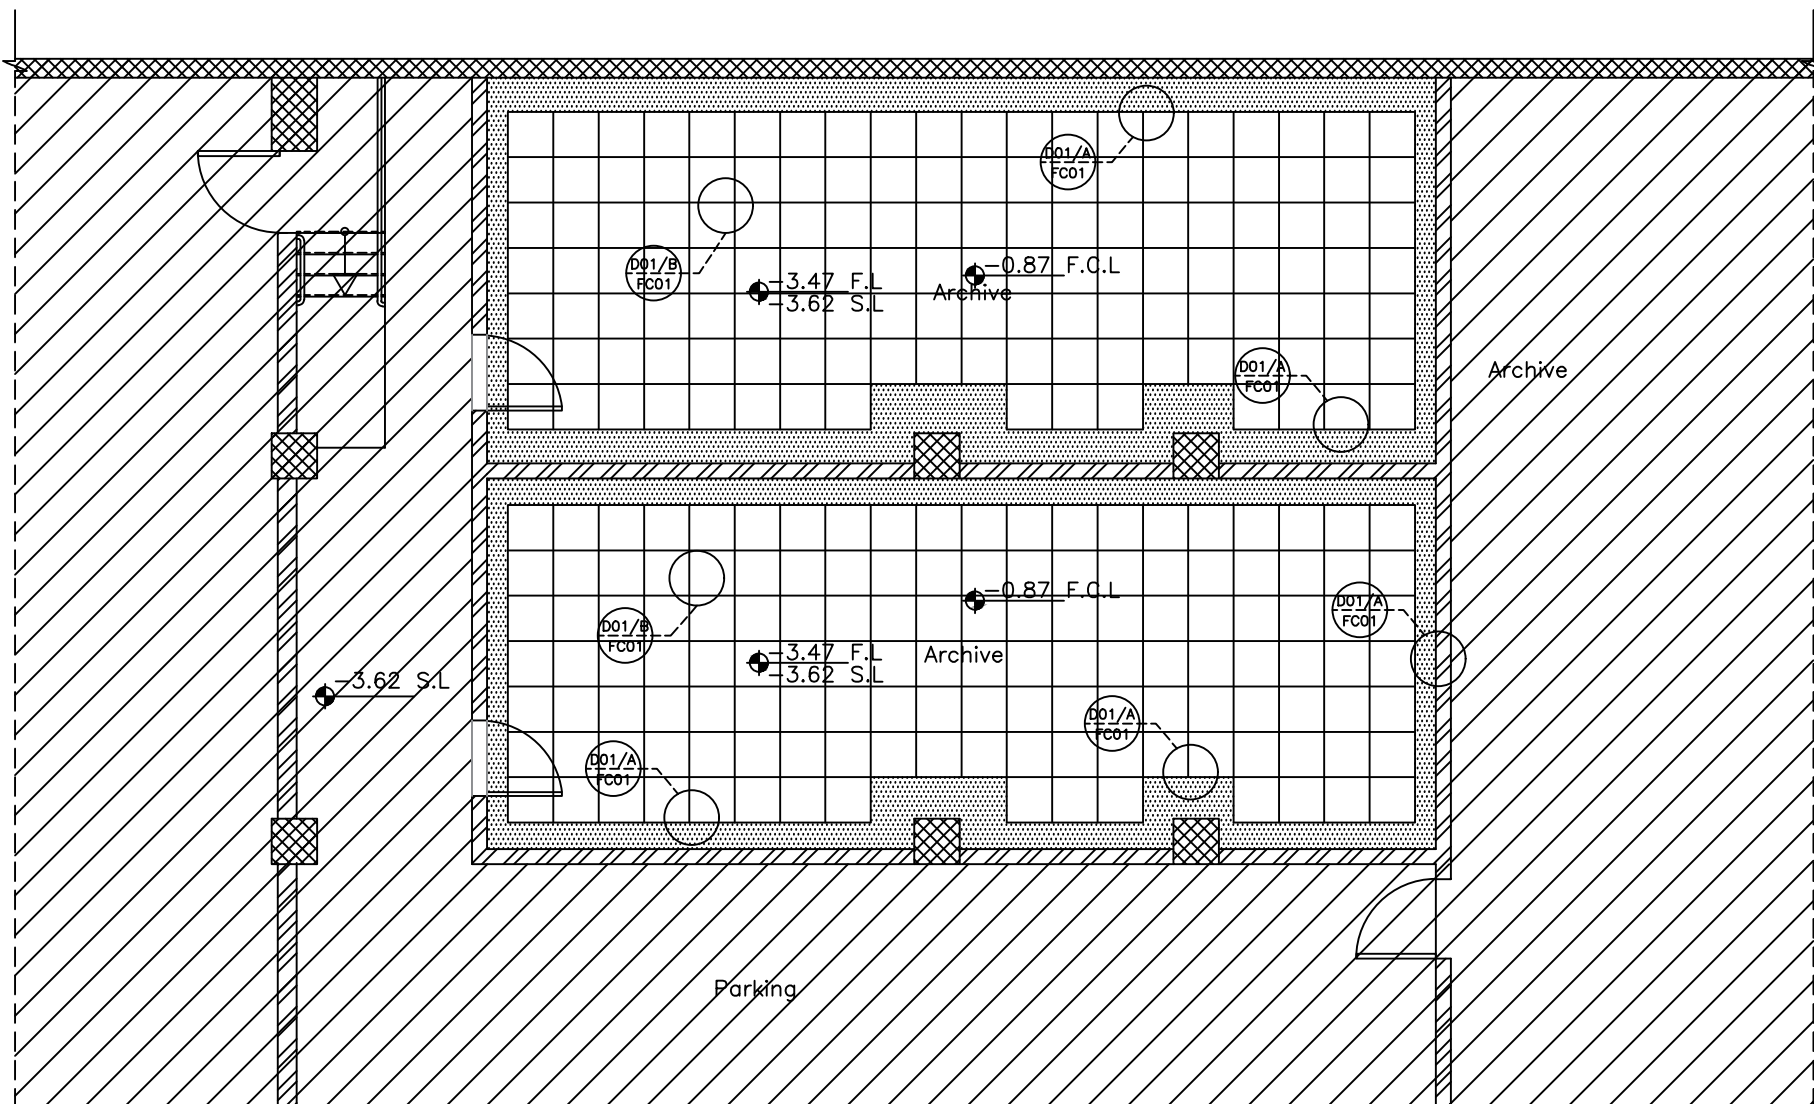

NOTES :

-  Section/elevation number drawing number.
-  Hollow blockwork.
-  Reinforced concrete column/wall .
-  Reinforced concrete jambs & sills .
-  Plain concrete walls.
-  Insulated gypsum board partitions.
-  F.F.L. Finished floor level .
-  F.L.L. Finished Lintel Level .
-  F.S.L. Finished Sill Level .
-  S.L. Slab level .
-  S.B.L. Slab bottom level.
-  F.L. Finished level .
-  R Radius

 EXISTING

-  600 X 600 MM ACOUSTIC TILES
-  METAL SHEETS REFLECTED CEILING
-  GYPSUM BOARD

REVISION	DATE OF REVISION	INITIALS	REVISION DETAILS
----------	------------------	----------	------------------



ESTABLISH A SPECIALIZED COURT
IN NABLUS

PROJECT No. :

ISSUE : TENDER


DRAWING : False Cieling Parking Floor

	DRAWN : SAFFARINI STAFF	APPROVED: SAFFARINI STAFF	DATE: JUNE, 2021
	NO :	NO. :	
	CHECKED: SAFFARINI STAFF	REF:	SCALE: 1/100

SAFFARINI & ASSOCIATES
Ramallah
Fax 02-2959363
Tel 02-2987675

A17

Rev.: 6

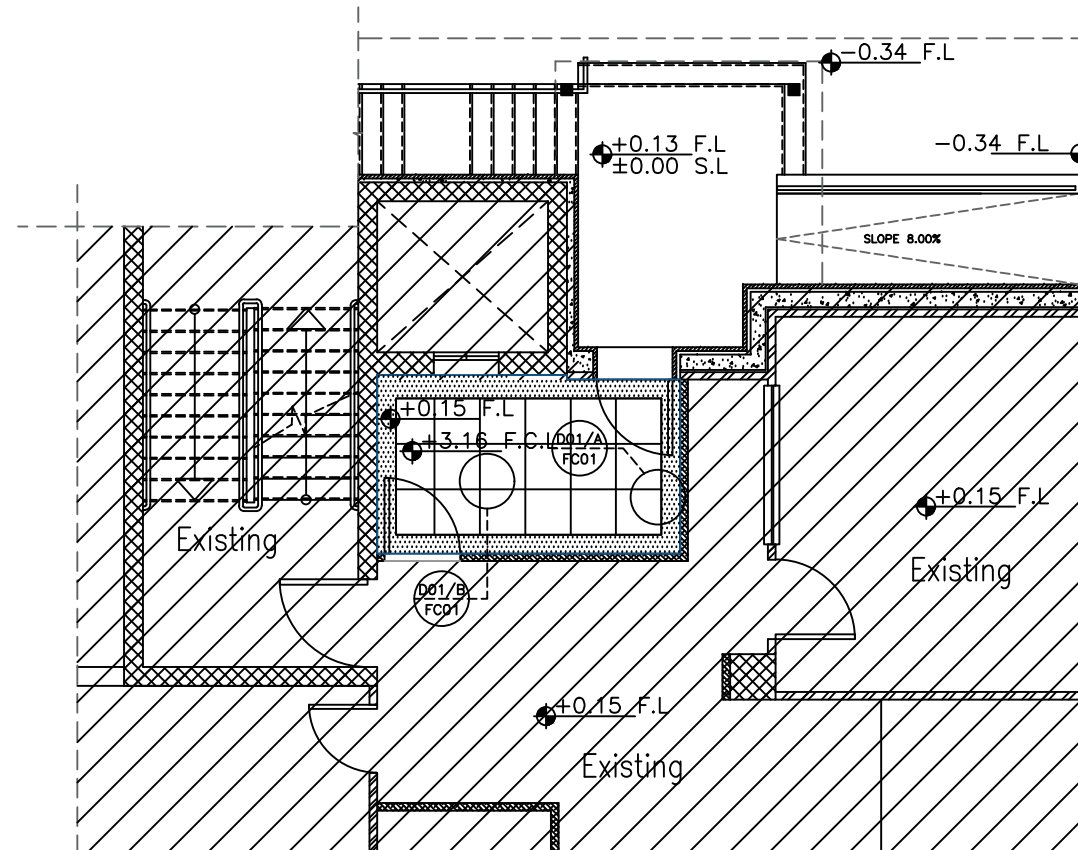

NOTES :

-  Section/elevation number drawing number.
-  Hollow blockwork.
-  Reinforced concrete column/wall .
-  Reinforced concrete jambs & sills .
-  Plain concrete walls.
-  Insulated gypsum board partitions.
-  F.F.L. Finished floor level .
-  F.L.L. Finished lintel level .
-  F.S.L. Finished sill level .
-  S.L. Slab level .
-  S.B.L. Slab bottom level.
-  F.L. Finished level .
-  R Radius

 EXISTING

-  600 X 600 MM ACOUSTIC TILES
-  METAL SHEETS REFLECTED CEILING
-  GYPSUM BOARD

REVISION	DATE OF REVISION	INITIALS	REVISION DETAILS



ESTABLISH A SPECIALIZED COURT
IN NABLUS

PROJECT No. :

ISSUE : TENDER


DRAWING : False Ceiling Ground Floor

	DRAWN : SAFFARINI STAFF	APPROVED: SAFFARINI STAFF	DATE: JUNE, 2021
	NO :	NO. :	
	CHECKED: SAFFARINI STAFF	REF:	SCALE: 1/100

SAFFARINI & ASSOCIATES
Ramallah
Fax 02-2959363
Tel 02-2987675

A18

Rev.: 6

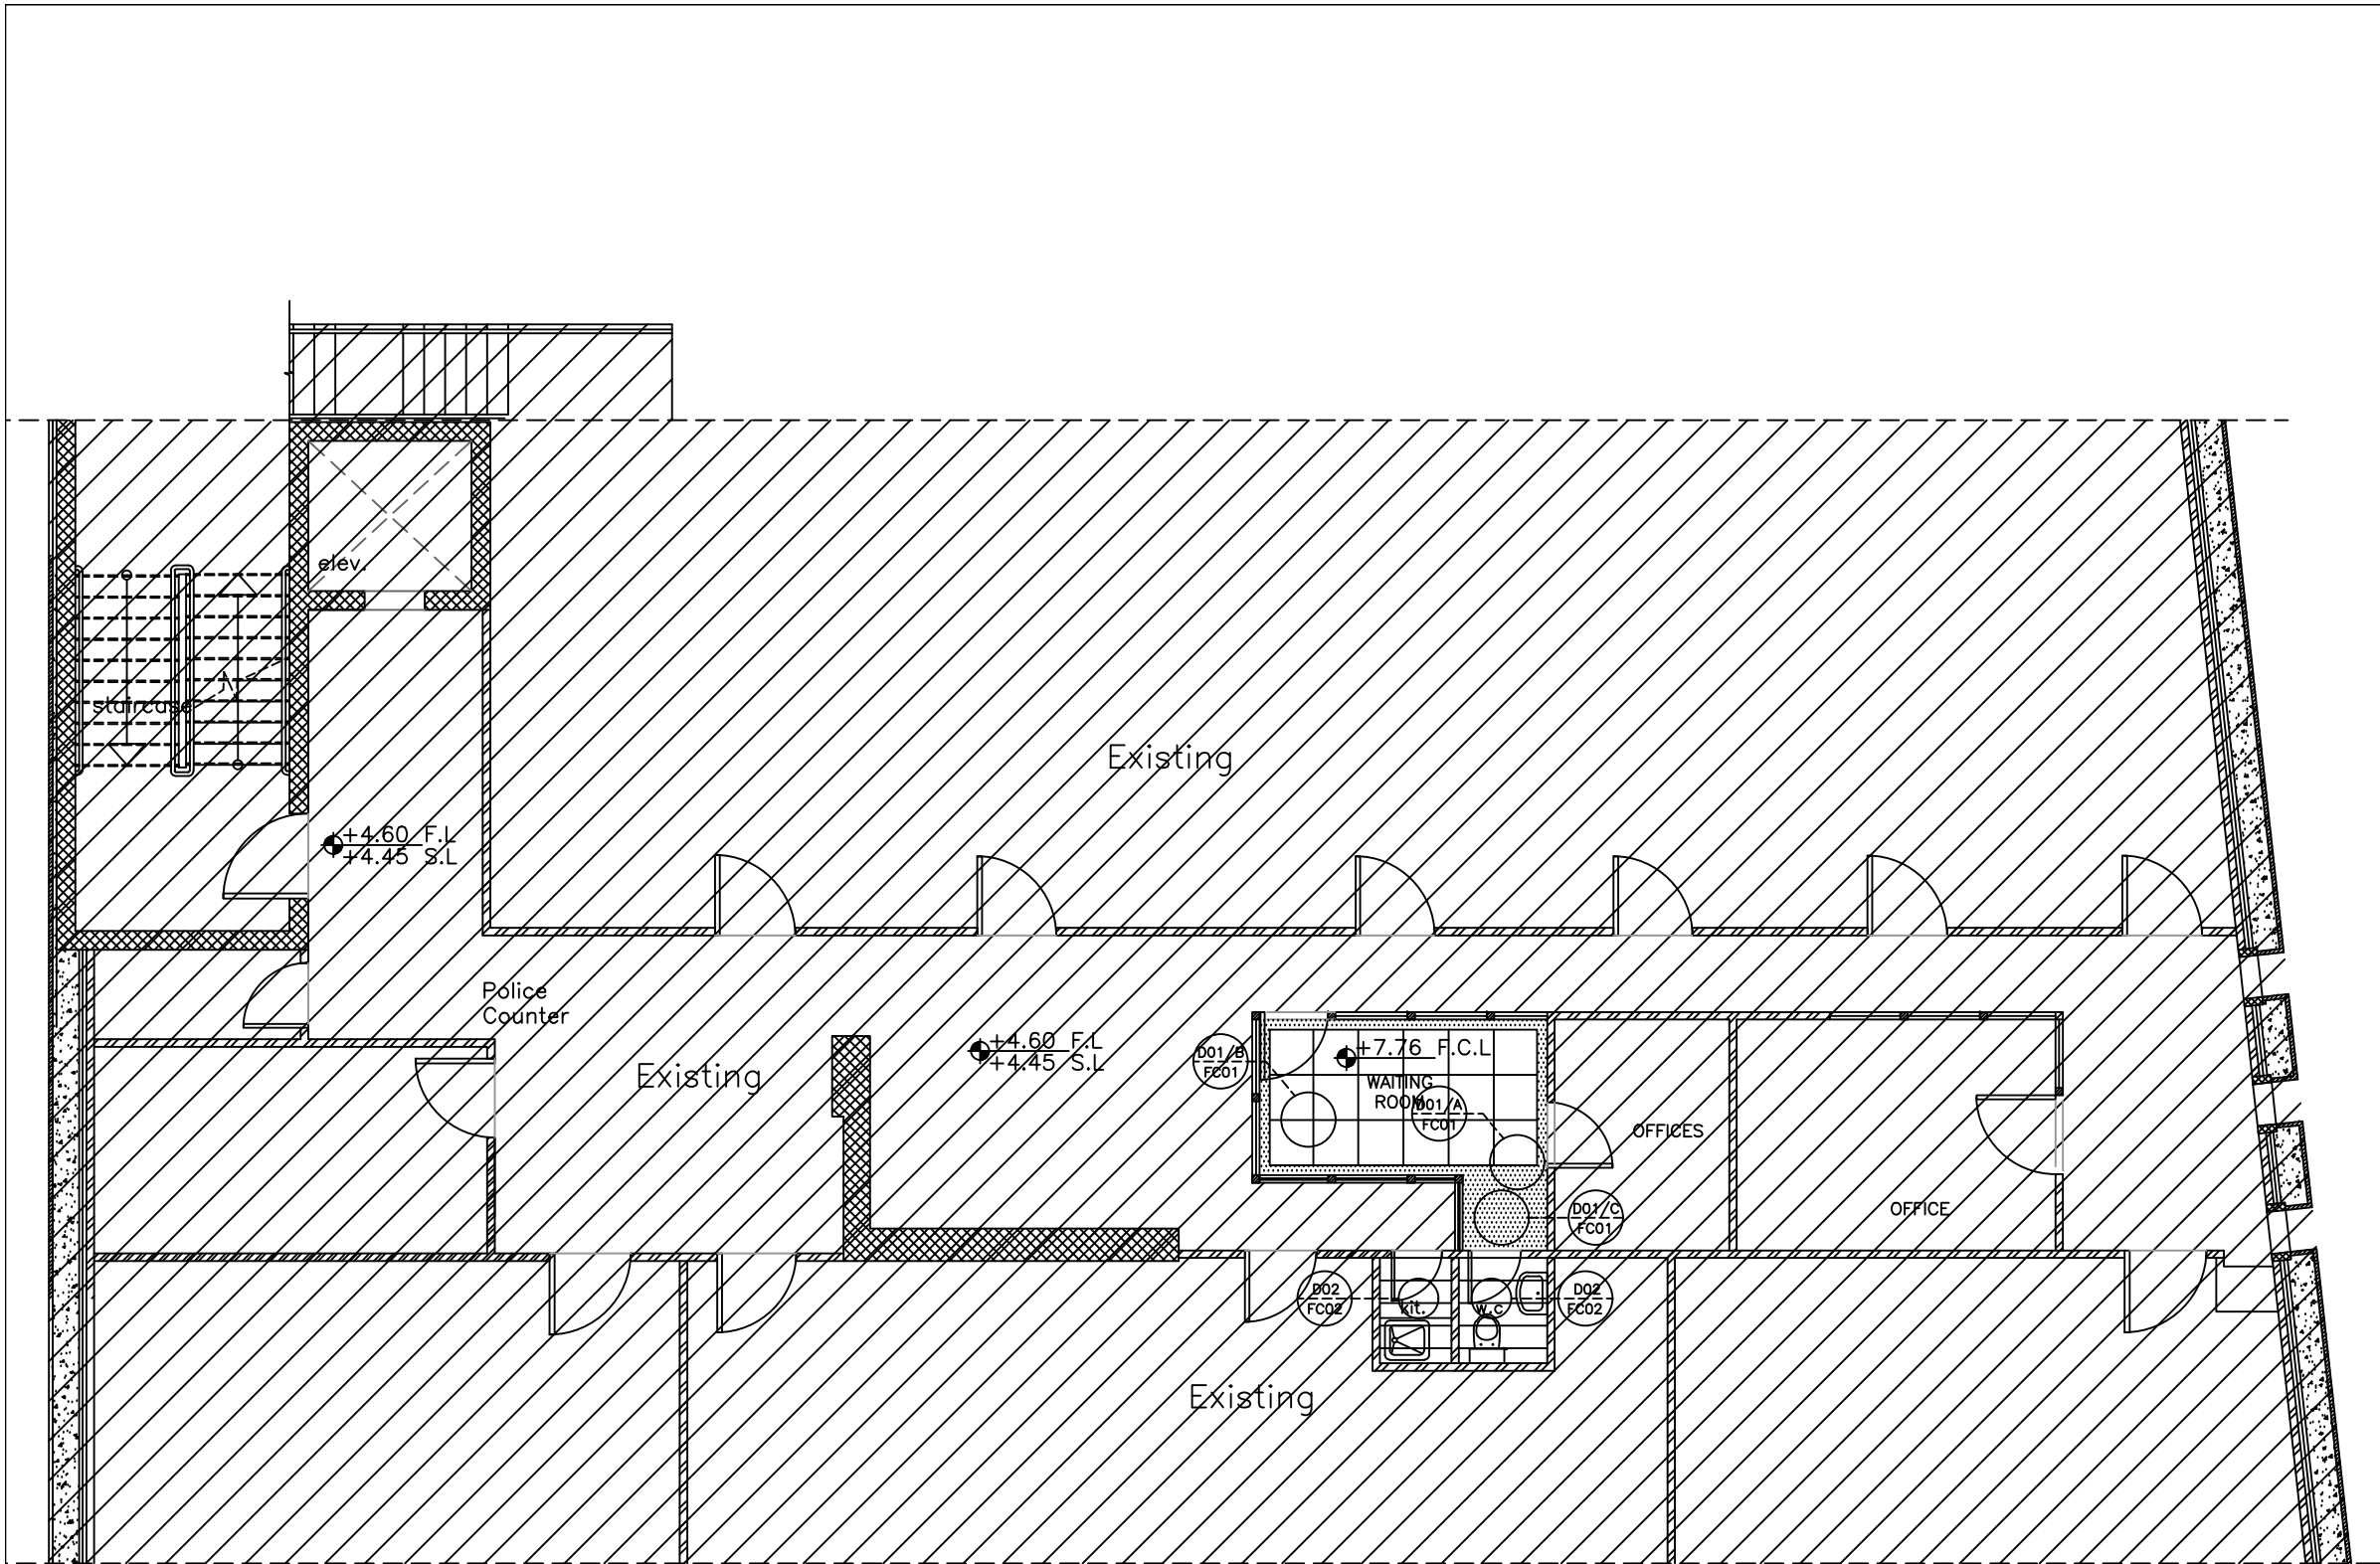

NOTES :

- Section/elevation number drawing number.
- Hollow blockwork.
- Reinforced concrete column/wall .
- Reinforced concrete jambs & sills .
- Plain concrete walls.
- Insulated gypsum board partitions.
- Finished floor level .
- Finished Lintel Level .
- Finished Sill Level .
- Slab level .
- Slab bottom level.
- Finished level .
- Radius

EXISTING

- 600 X 600 MM ACOUSTIC TILES
- METAL SHEETS REFLECTED CEILING
- GYPSUM BOARD

REVISION	DATE OF REVISION	INITIALS	REVISION DETAILS
----------	------------------	----------	------------------



ESTABLISH A SPECIALIZED COURT
IN NABLUS

PROJECT No. :

ISSUE : TENDER


DRAWING : False Ceiling First Floor

DRAWN : SAFFARINI STAFF NO : CHECKED: SAFFARINI STAFF NO :	APPROVED: SAFFARINI STAFF NO. : REF:	DATE: JUNE, 2021
		SCALE: 1/100

SAFFARINI & ASSOCIATES
Ramallah
Fax 02-2959363
Tel 02-2987675

A19

Rev.: 6

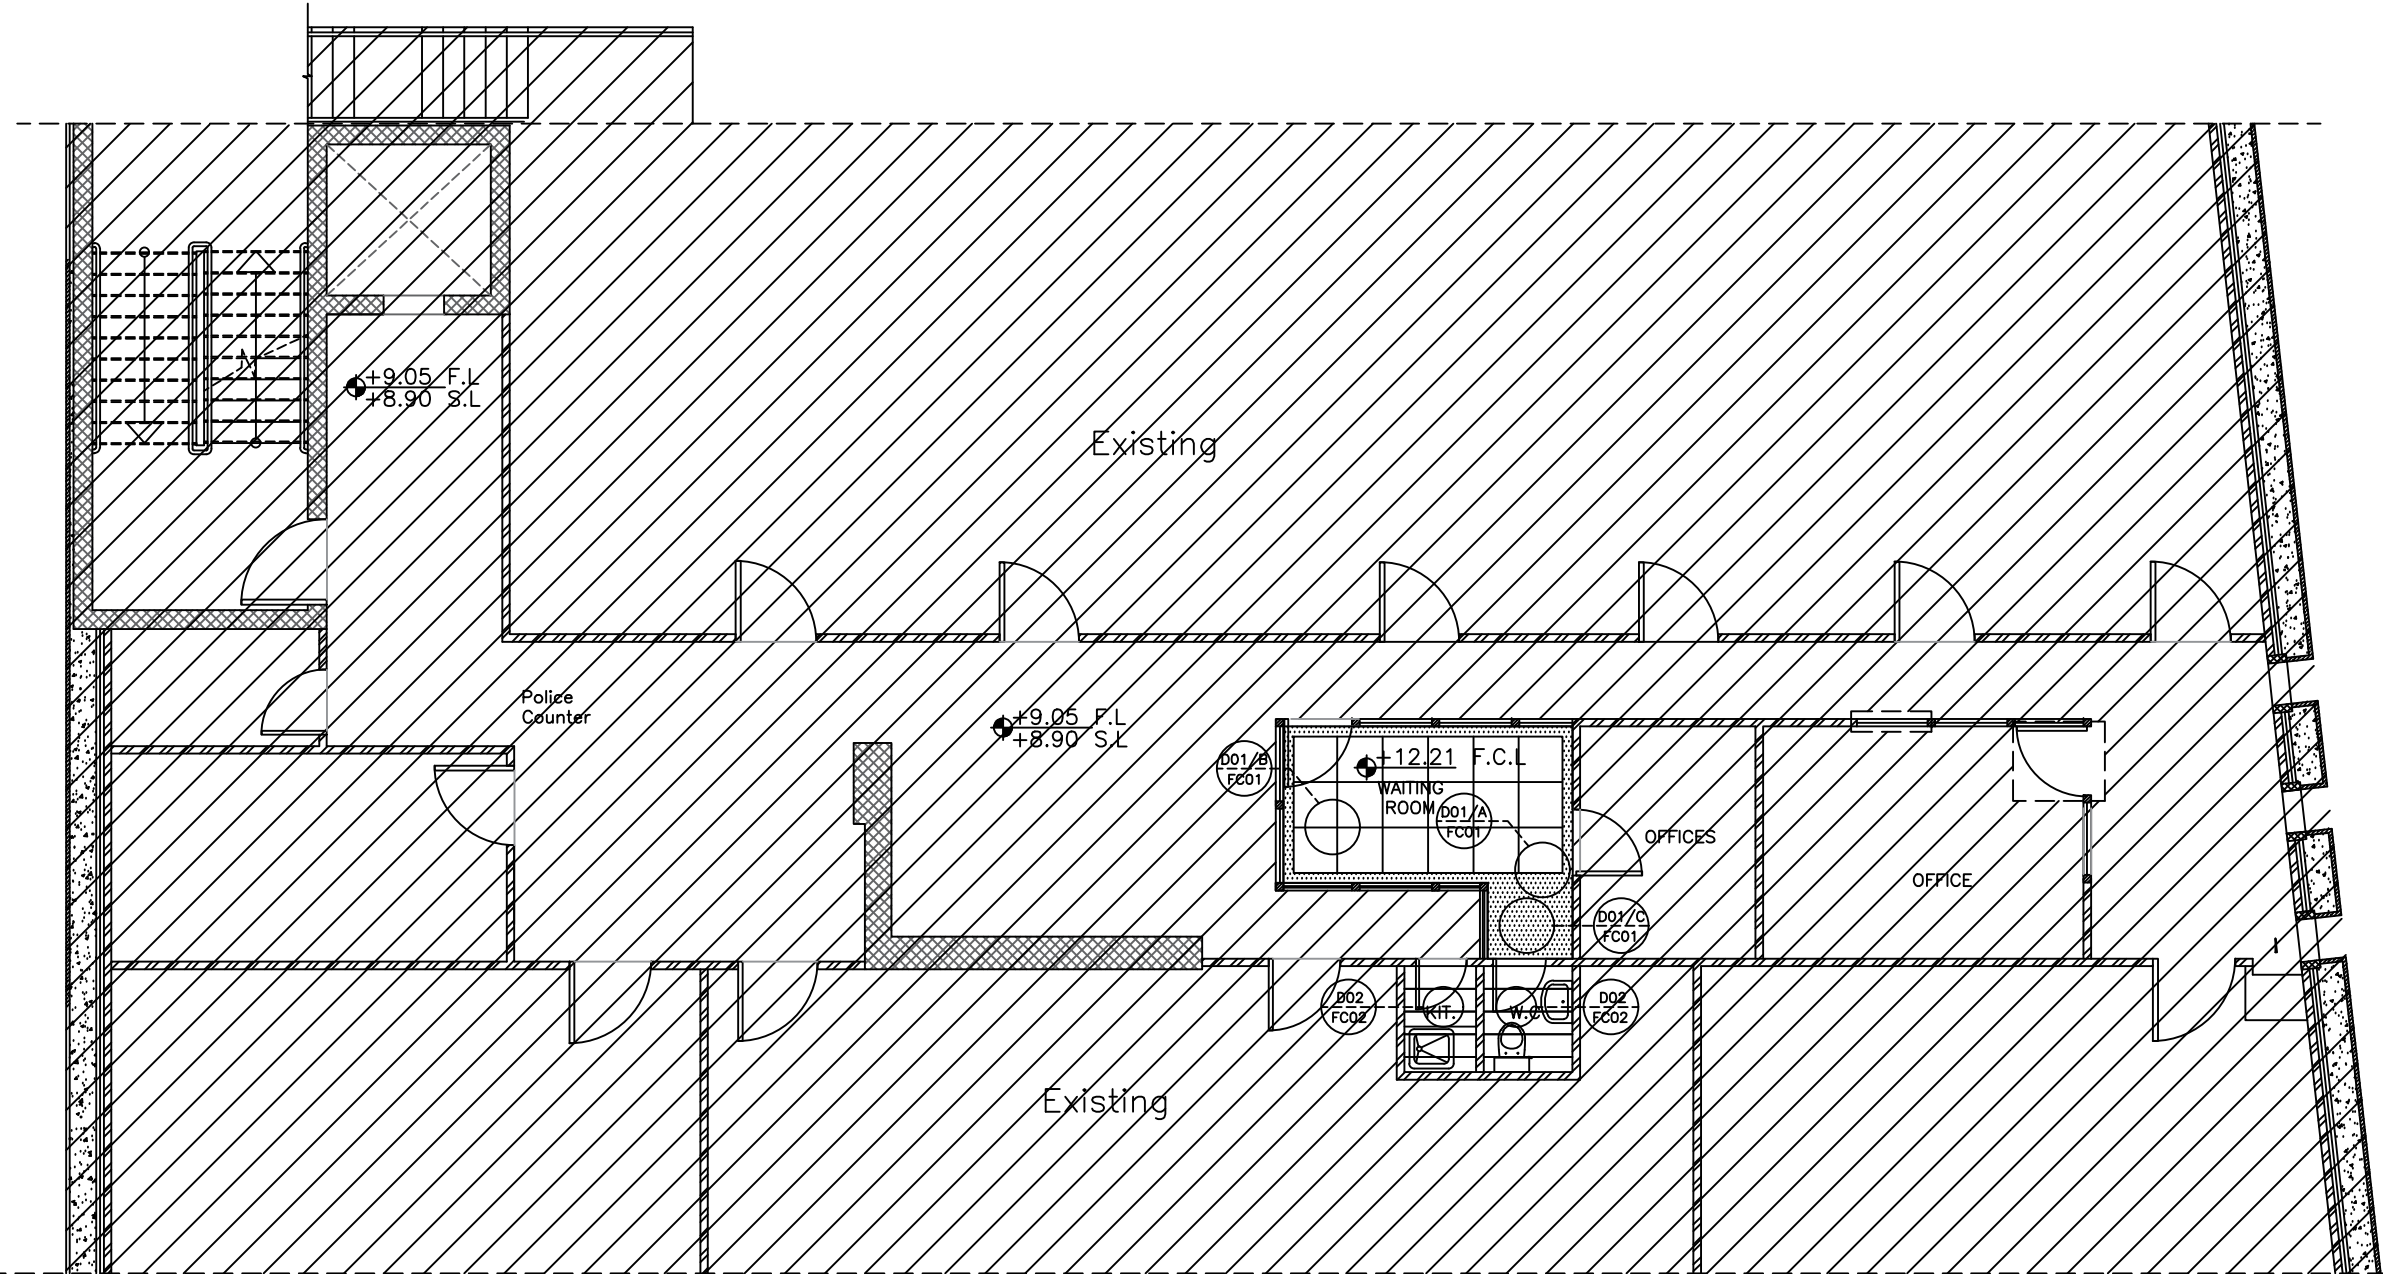

NOTES :

-  Section/elevation number drawing number.
-  Hollow blockwork.
-  Reinforced concrete column/wall .
-  Reinforced concrete jambs & sills .
-  Plain concrete walls.
-  Insulated gypsum board partitions.
-  F.F.L. Finished floor level .
-  F.L.L. Finished lintel level .
-  F.S.L. Finished sill level .
-  S.L. Slab level .
-  S.B.L. Slab bottom level.
-  F.L. Finished level .
-  R Radius

 EXISTING

-  600 X 600 MM ACOUSTIC TILES
-  METAL SHEETS REFLECTED CEILING
-  GYPSUM BOARD

REVISION	DATE OF REVISION	INITIALS	REVISION DETAILS
----------	------------------	----------	------------------



ESTABLISH A SPECIALIZED COURT
IN NABLUS

PROJECT No. :

ISSUE : TENDER


DRAWING : False Ceiling Second Floor

	DRAWN : SAFFARINI STAFF	APPROVED: SAFFARINI STAFF	DATE: JUNE, 2021
	NO :	NO. :	
	CHECKED: SAFFARINI STAFF	REF:	SCALE: 1/100

SAFFARINI & ASSOCIATES
Ramallah
Fax 02-2959363
Tel 02-2987675

A20

Rev.: 6

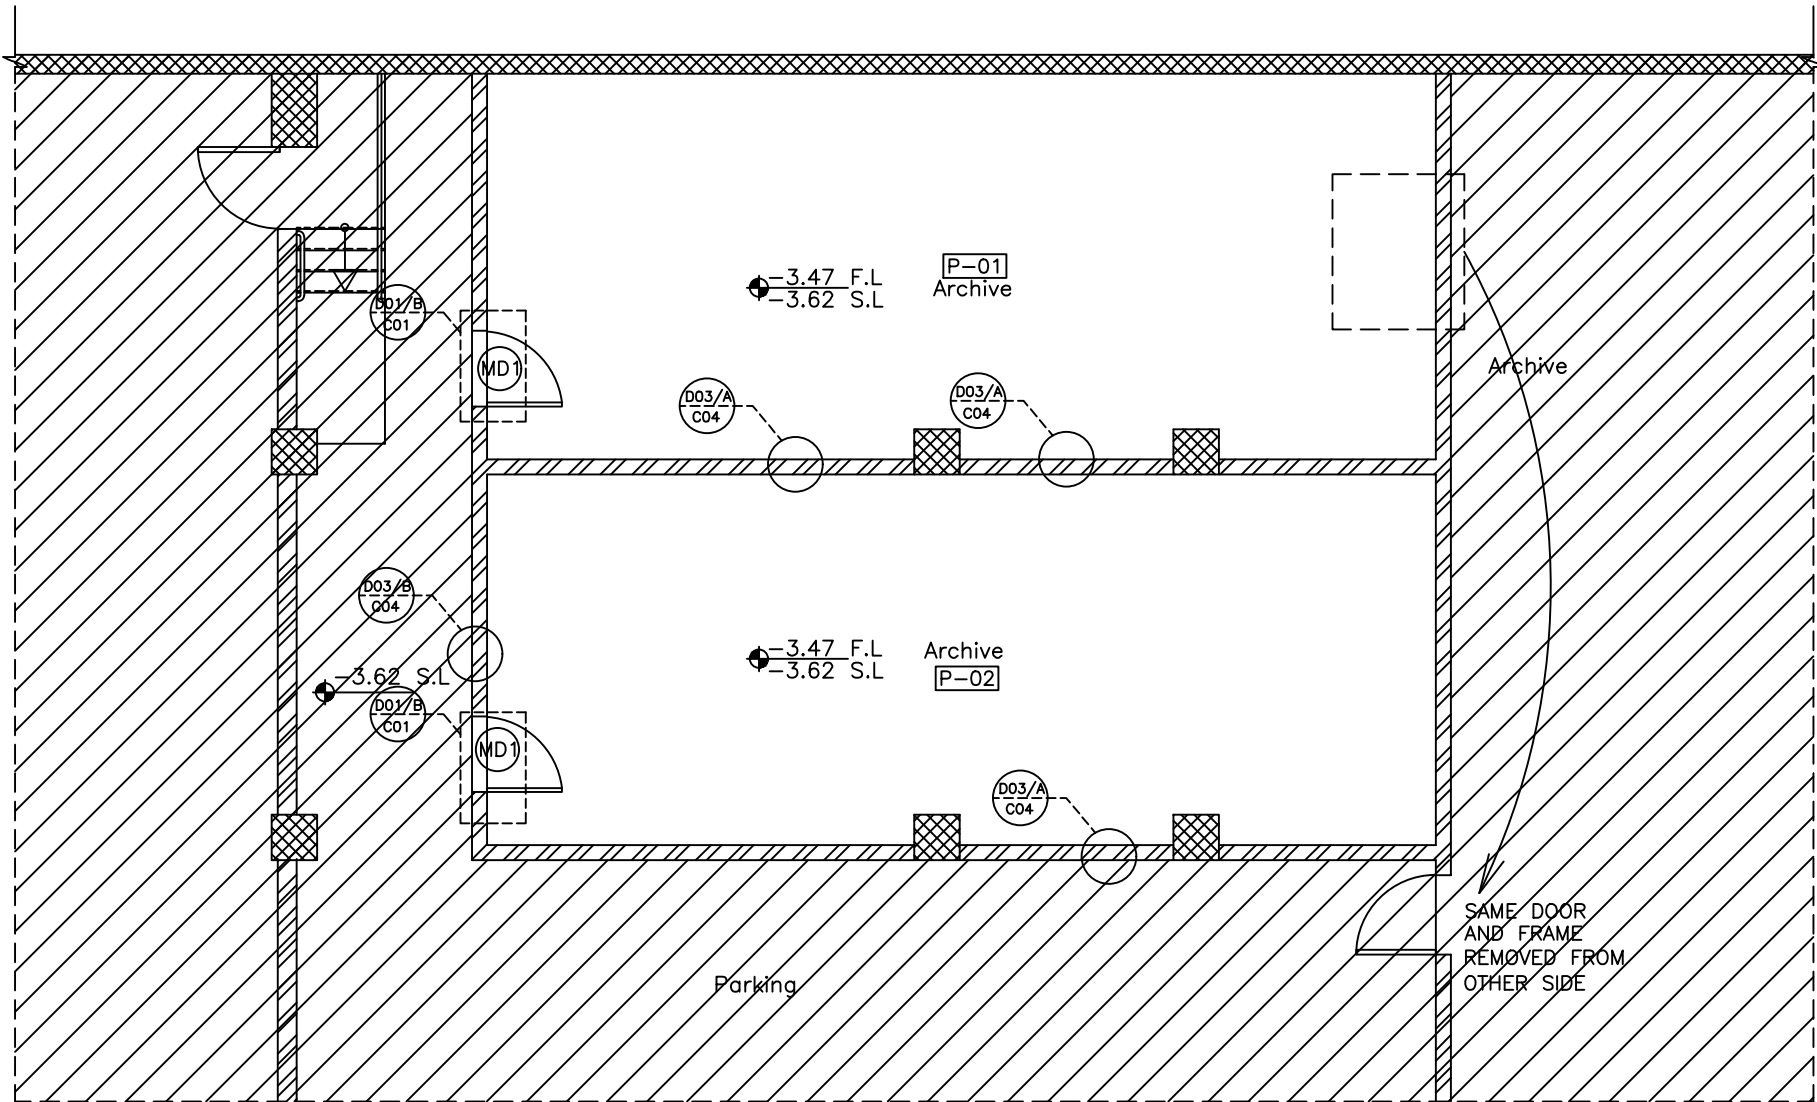

SCHEDULE OF FINISHES

SPACE NO.	SPACE USE	FLOOR FINISH	CEILING FINISH	WALL FINISHES
P-1	ARCHIVE	300x300x30MM TERRAZZO TILES W/ 70MM HIGH TILE SKIRTING	GYPSUM BOARD & 600 X 600 MM ACOUSTIC TILES	3 COATS PLASTER WITH 2 COATS PUTTY FILLER & 1 PRIMER PAINT COAT & 2 FINISHING COATS OIL PAINT TO 1500 MM HEIGHT & 2 FINISHING COATS EMULSION PAINT TO THE REST OF WALLS
P-2	ARCHIVE	300x300x30MM TERRAZZO TILES W/ 70MM HIGH TILE SKIRTING	GYPSUM BOARD & 600 X 600 MM ACOUSTIC TILES	3 COATS PLASTER WITH 2 COATS PUTTY FILLER & 1 PRIMER PAINT COAT & 2 FINISHING COATS OIL PAINT TO 1500 MM HEIGHT & 2 FINISHING COATS EMULSION PAINT TO THE REST OF WALLS

NOTES :

- Section/elevation number drawing number.
- Hollow blockwork.
- Reinforced concrete column/wall .
- Reinforced concrete jambs & sills .
- Plain concrete walls.
- Insulated gypsum board partitions.
- F.F.L. Finished floor level .
- F.L.L. Finished Lintel Level .
- F.S.L. Finished Sill Level .
- S.L. Slab level .
- S.B.L. Slab bottom level.
- F.L. Finished level .
- R Radius

EXISTING



ESTABLISH A SPECIALIZED COURT
IN NABLUS

PROJECT No. :

ISSUE : TENDER


DRAWING : PARKING FLOOR TAGS
& REFERENCE PLAN

	DRAWN : SAFFARINI STAFF NO. : CHECKED: SAFFARINI STAFF NO. :	APPROVED: SAFFARINI STAFF NO. : REF:	DATE: JUNE, 2021 SCALE: 1/100
--	---	--	----------------------------------

SAFFARINI & ASSOCIATES
Ramallah
Fax 02-2959363
Tel 02-2987675

A21

Rev.: 6

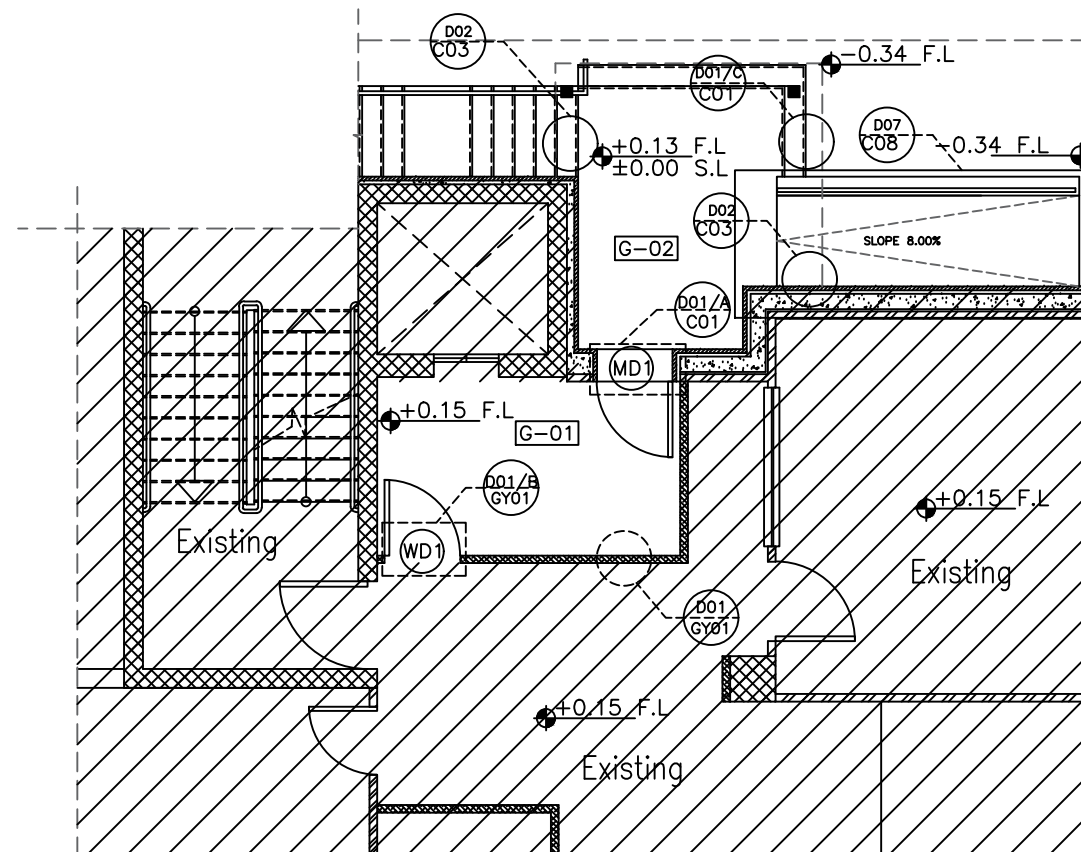

SCHEDULE OF FINISHES

SPACE NO.	SPACE USE	FLOOR FINISH	CEILING FINISH	WALL FINISHES
G-1	ENTRANCE	EXISTING TILES	GYPSUM BOARD & 600 X 600 MM ACOUSTIC TILES	FOR GYPSUM BOARD: EMULSION PAINT FOR CONCRETE WALL 3 COATS PLASTER WITH 2 COATS PUTTY FILLER & 1 PRIMER PAINT COAT & 2 FINISHING COATS OIL PAINT TO 1500 MM HEIGHT & 2 FINISHING COATS EMULSION PAINT TO THE REST OF WALLS
G-2	EXTERNAL	500x250x50MM STONE TILE	GYPSUM BOARD & 600 X 600 MM ACOUSTIC TILES	

NOTES :

- Section/elevation number drawing number.
- Hollow blockwork.
- Reinforced concrete column/wall .
- Reinforced concrete jambs & sills .
- Plain concrete walls.
- Insulated gypsum board partitions.
- F.F.L. Finished floor level .
- F.L.L. Finished Lintel Level .
- F.S.L. Finished Sill Level .
- S.L. Slab level .
- S.B.L. Slab bottom level.
- F.L. Finished level .
- R Radius

EXISTING



ESTABLISH A SPECIALIZED COURT
IN NABLUS

PROJECT No. :

ISSUE : TENDER


DRAWING : GROUND FLOOR TAGS
& REFERENCE PLAN

	DRAWN : SAFFARINI STAFF NO. :	APPROVED: SAFFARINI STAFF NO. :	DATE: JUNE, 2021
	CHECKED: SAFFARINI STAFF NO. :	REF:	SCALE: 1/100

SAFFARINI & ASSOCIATES
Ramallah
Fax 02-2959363
Tel 02-2987675

A22

Rev.: 6

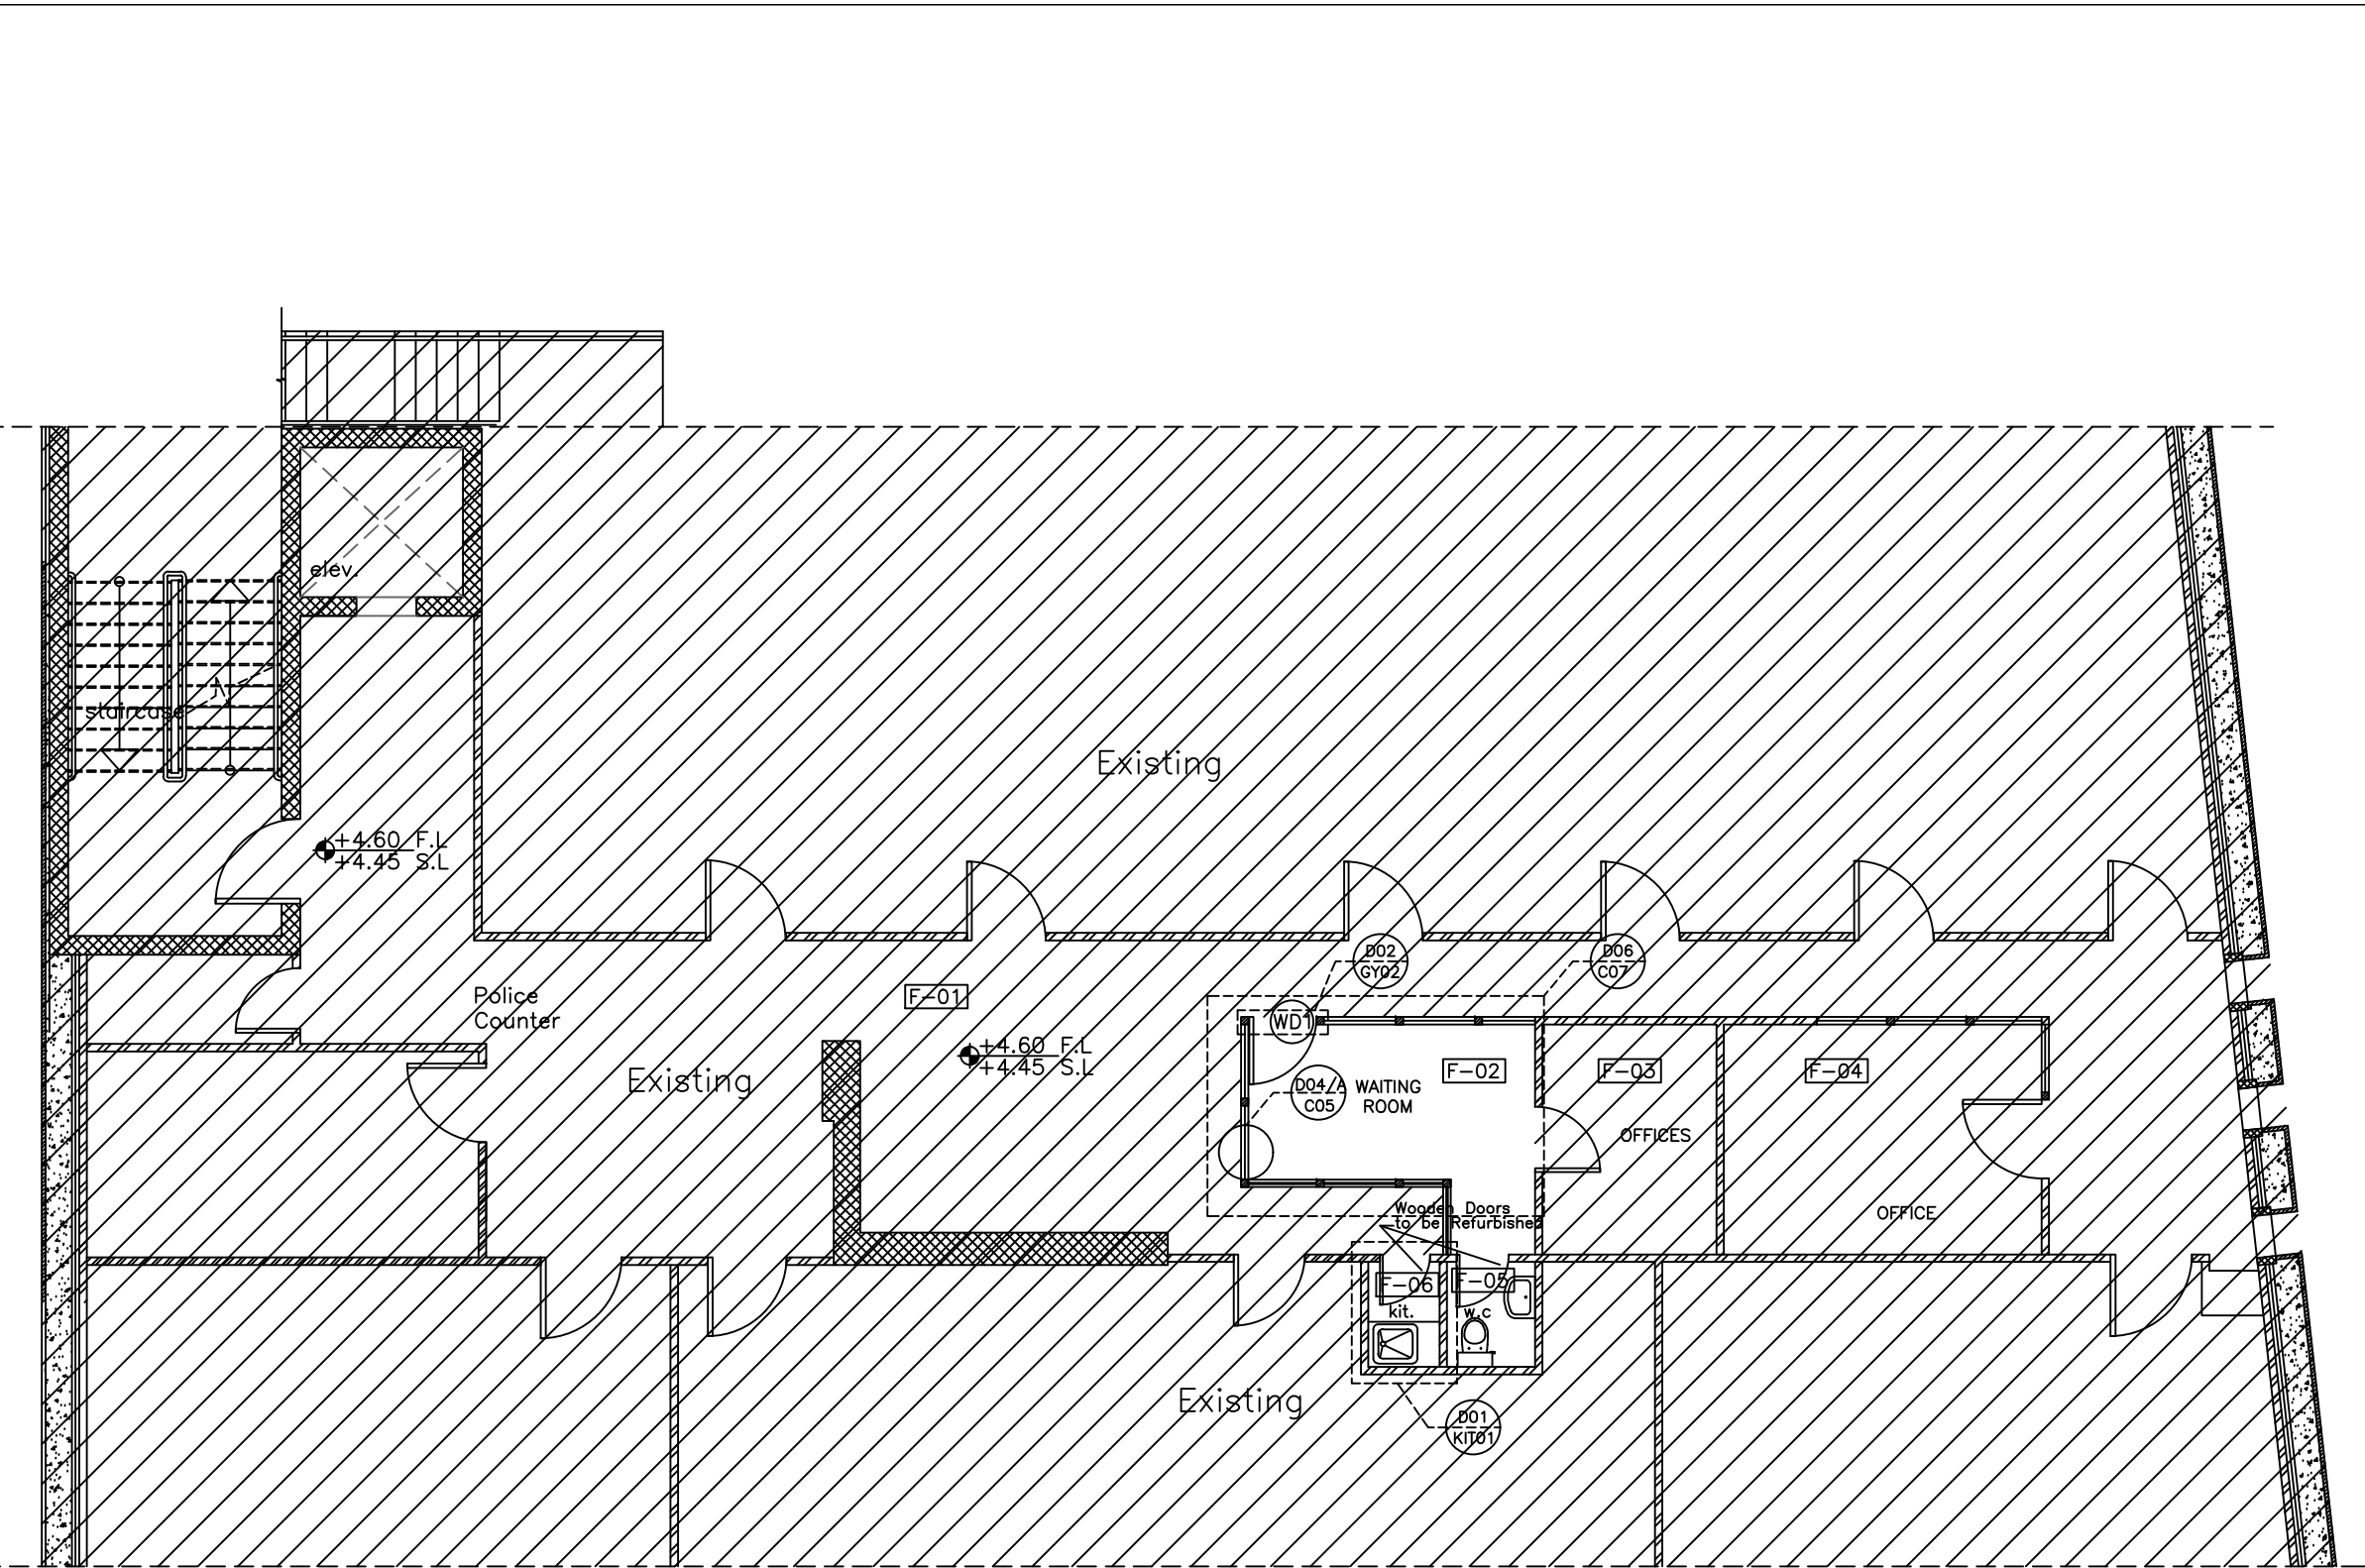

SCHEDULE OF FINISHES

SPACE NO.	SPACE USE	FLOOR FINISH	CEILING FINISH	WALL FINISHES
F-1	CORRIDOR	----	PAINT	----
F-2	WAITING AREA	----	GYPSUM BOARD & 600 X 600 MM ACOUSTIC TILES	EMULSION PAINT
F-2	OFFICE	----	GYPSUM BOARD & 600 X 600 MM ACOUSTIC TILES	EMULSION PAINT
F-2	OFFICE	----	GYPSUM BOARD & 600 X 600 MM ACOUSTIC TILES	EMULSION PAINT

SCHEDULE OF FINISHES

SPACE NO.	SPACE USE	FLOOR FINISH	CEILING FINISH	WALL FINISHES
F-5	WC	----	METAL SHEETS REFLECTED CEILING	----
F-6	KITCHEN	----	METAL SHEETS REFLECTED CEILING	60cm GRANITE TILE ABOVE CABINET

NOTES :

-  Section/elevation number drawing number.
-  Hollow blockwork.
-  Reinforced concrete column/wall .
-  Reinforced concrete jambs & sills .
-  Plain concrete walls.
-  Insulated gypsum board partitions.
-  F.F.L Finished floor level .
-  F.L.L Finished lintel level .
-  F.S.L Finished sill level .
-  S.L Slab level .
-  S.B.L Slab bottom level.
-  F.L Finished level .
-  R Radius

 EXISTING

REVISION	DATE OF REVISION	INITIALS	REVISION DETAILS
----------	------------------	----------	------------------



ESTABLISH A SPECIALIZED COURT
IN NABLUS

PROJECT No. :

ISSUE : TENDER


FIRST FLOOR TAGS
& REFERENCE PLAN

	DRAWN : SAFFARINI STAFF NO. :	APPROVED: SAFFARINI STAFF NO. :	DATE: JUNE, 2021
	CHECKED: SAFFARINI STAFF NO. :	REF:	SCALE: 1/100

SAFFARINI & ASSOCIATES
Ramallah
Fax 02-2959363
Tel 02-2987675

A23

Rev.: 6

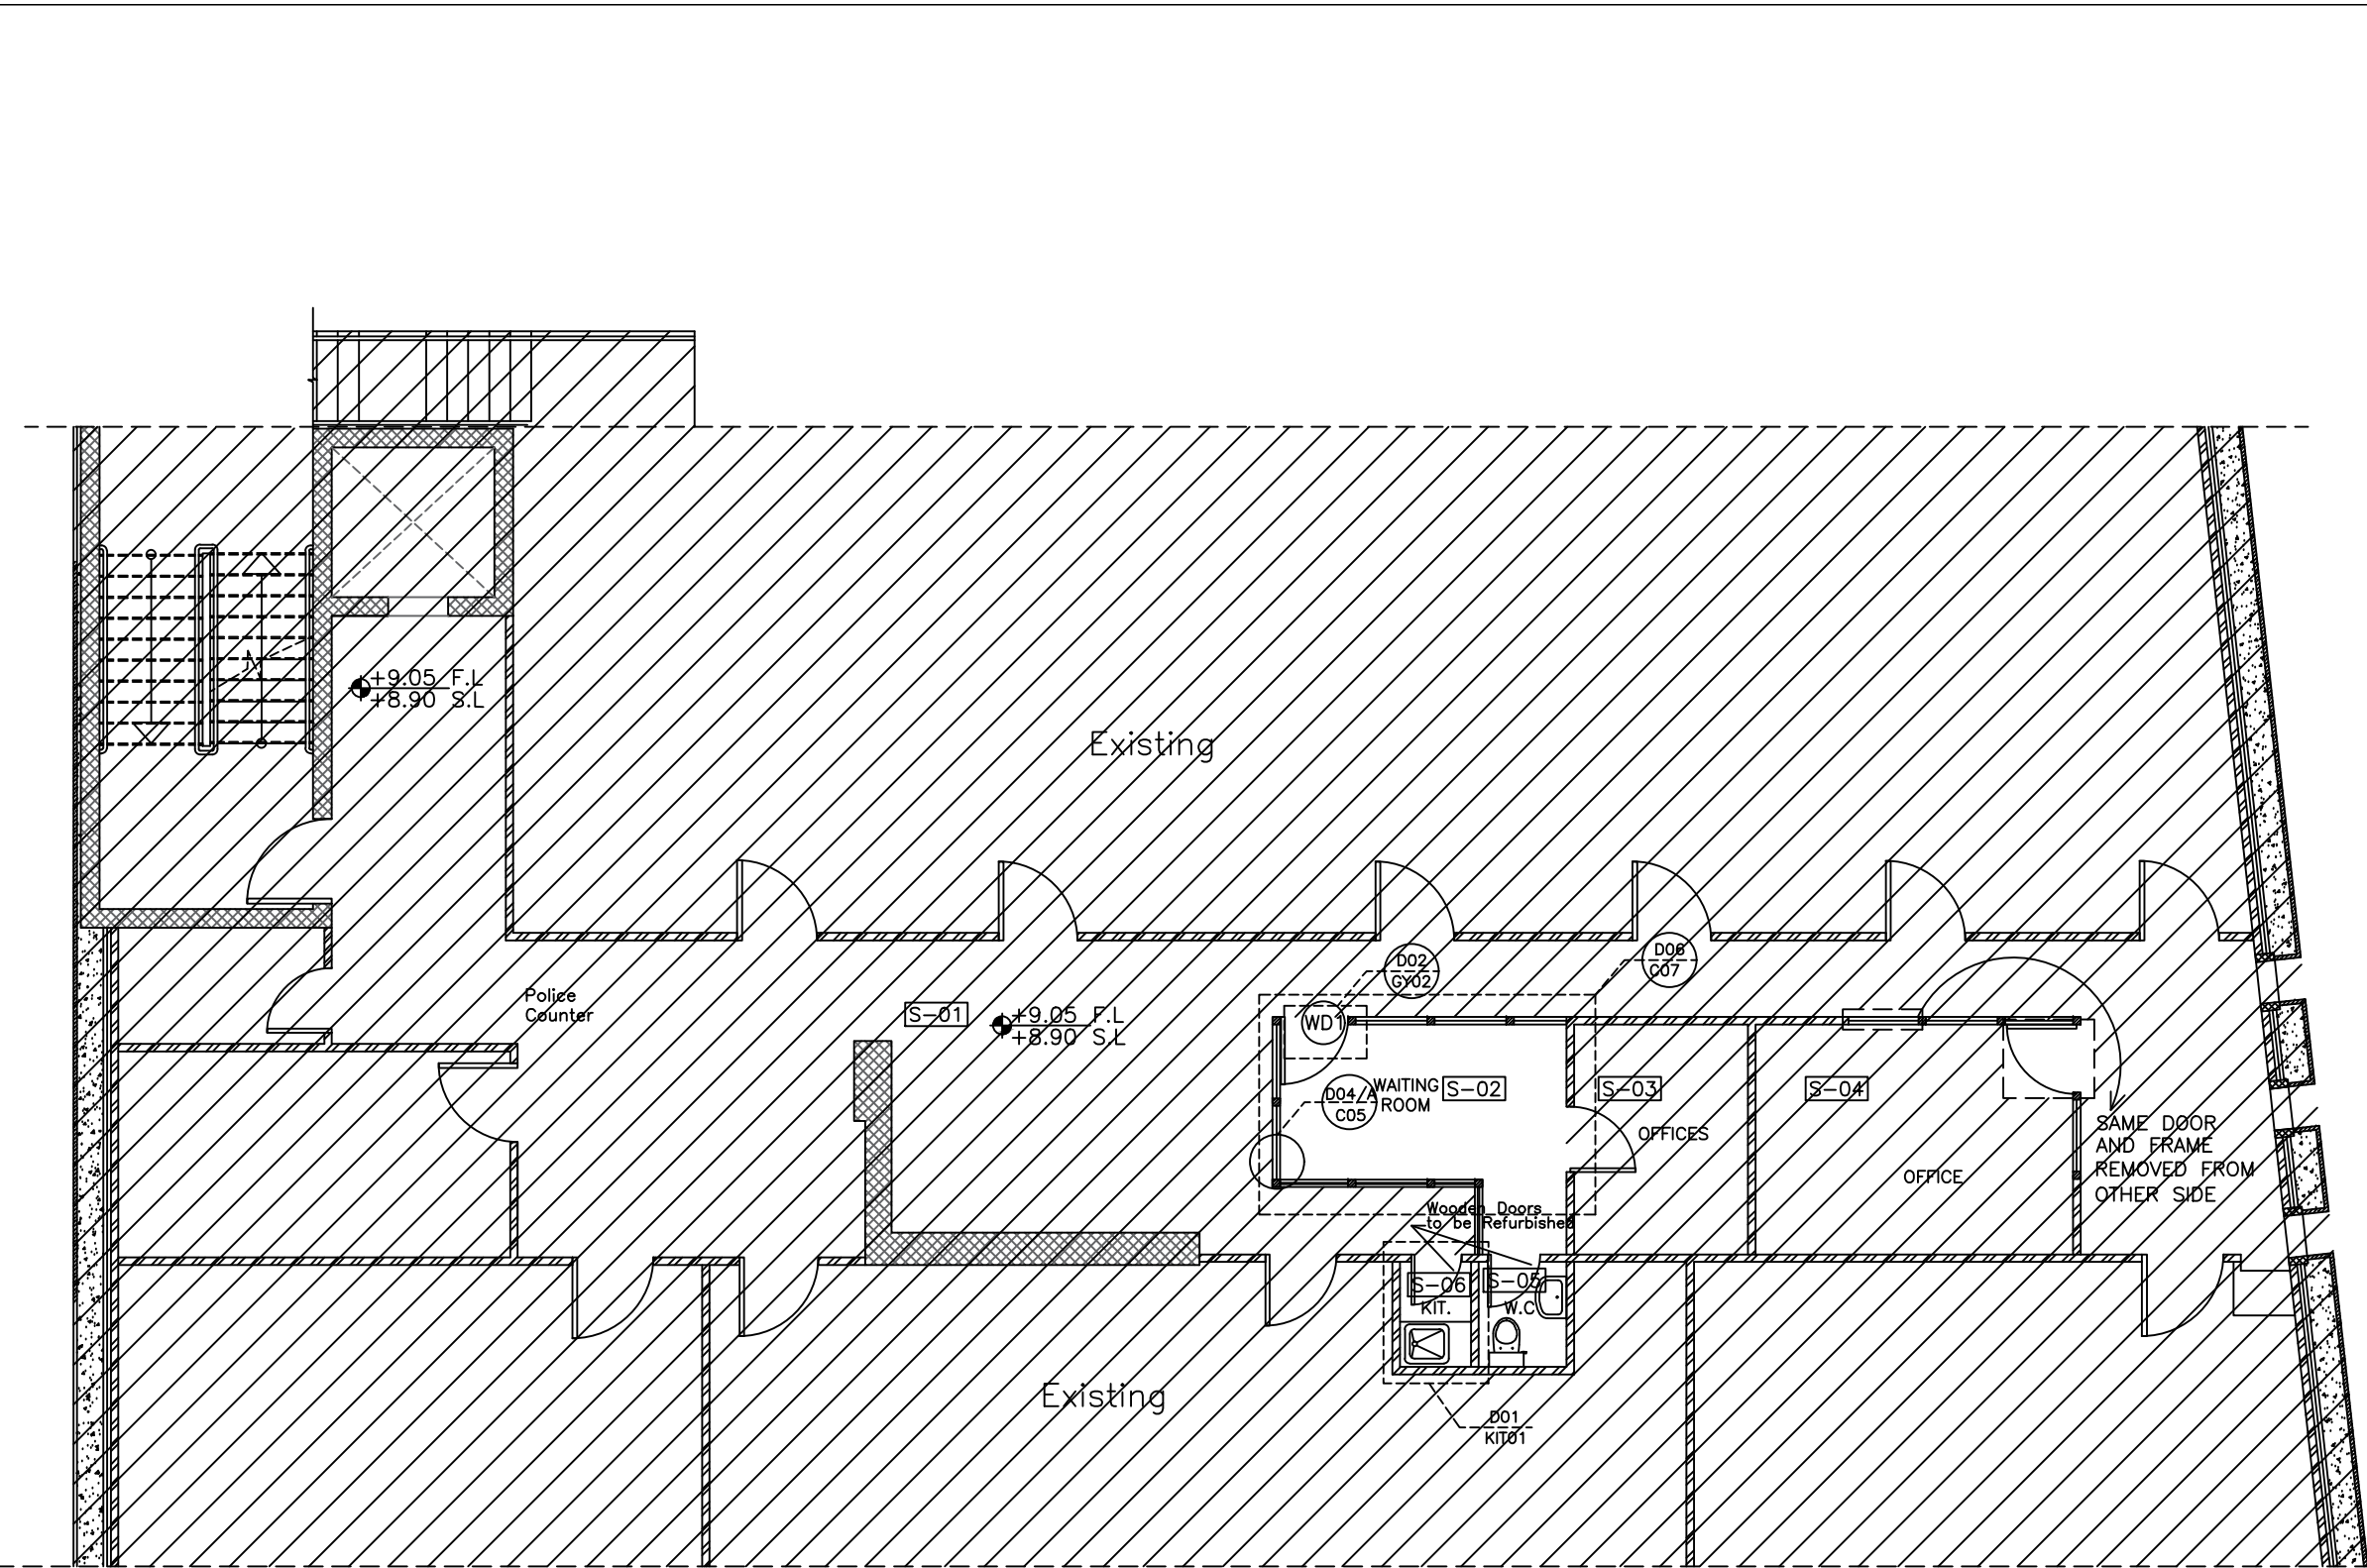

SCHEDULE OF FINISHES

SPACE NO.	SPACE USE	FLOOR FINISH	CEILING FINISH	WALL FINISHES
S-1	CORRIDOR	----	PAINT	----
S-2	WAITING AREA	----	GYPSUM BOARD & 600 X 600 MM ACOUSTIC TILES	EMULSION PAINT
S-3	OFFICE	----	GYPSUM BOARD & 600 X 600 MM ACOUSTIC TILES	EMULSION PAINT
S-4	OFFICE	----	GYPSUM BOARD & 600 X 600 MM ACOUSTIC TILES	EMULSION PAINT

SCHEDULE OF FINISHES

SPACE NO.	SPACE USE	FLOOR FINISH	CEILING FINISH	WALL FINISHES
S-5	WC	----	METAL SHEETS REFLECTED CEILING	----
S-6	KITCHEN	----	METAL SHEETS REFLECTED CEILING	60cm GRANITE TILE ABOVE CABINET

NOTES :

-  Section/elevation number drawing number.
-  Hollow blockwork.
-  Reinforced concrete column/wall .
-  Reinforced concrete jambs & sills .
-  Plain concrete walls.
-  Insulated gypsum board partitions.
-  F.F.L Finished floor level .
-  F.L.L Finished lintel level .
-  F.S.L Finished sill level .
-  S.L Slab level .
-  S.B.L Slab bottom level.
-  F.L Finished level .
-  R Radius

 EXISTING

REVISION	DATE OF REVISION	INITIALS	REVISION DETAILS
----------	------------------	----------	------------------



ESTABLISH A SPECIALIZED COURT
IN NABLUS

PROJECT No. :

ISSUE : TENDER




SECOND FLOOR TAGS
& REFERENCE PLAN

	DRAWN : SAFFARINI STAFF	APPROVED: SAFFARINI STAFF	DATE: JUNE, 2021
	NO. :	NO. :	
	CHECKED: SAFFARINI STAFF	REF:	SCALE: 1/100

SAFFARINI & ASSOCIATES
Ramallah
Fax 02-2959363
Tel 02-2987675

A24

Rev.: 6

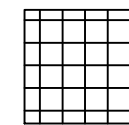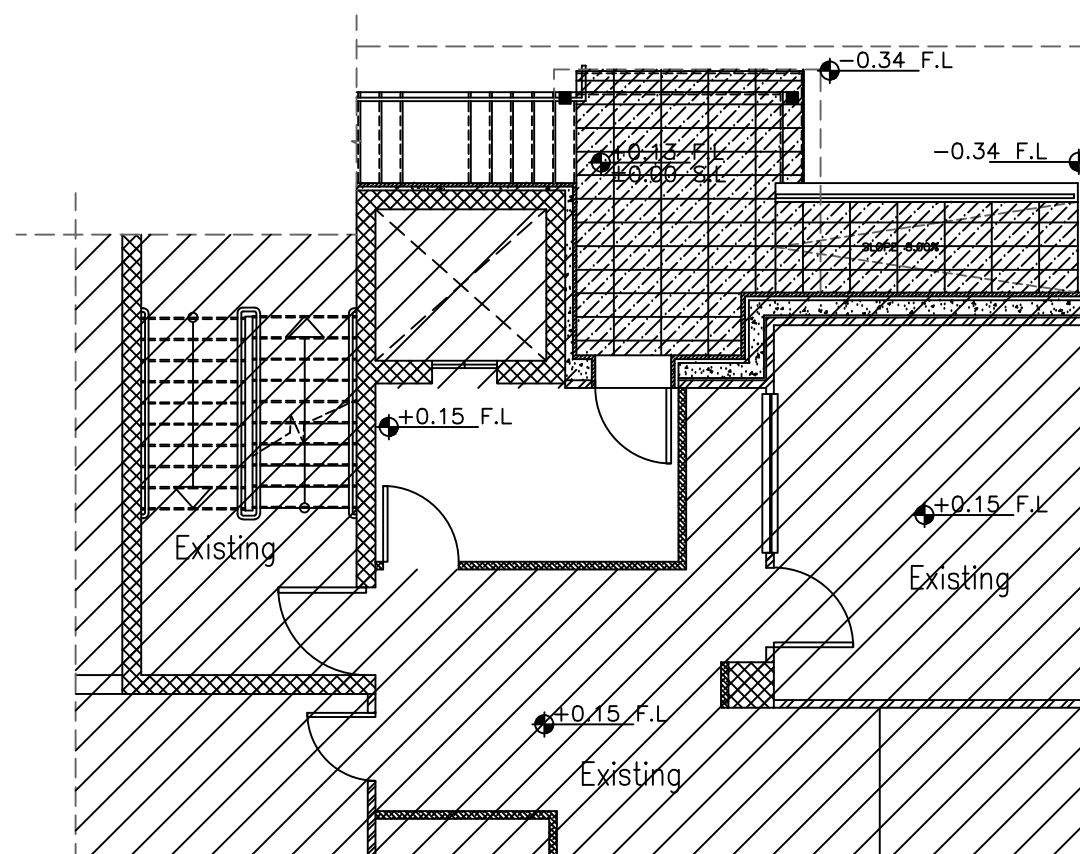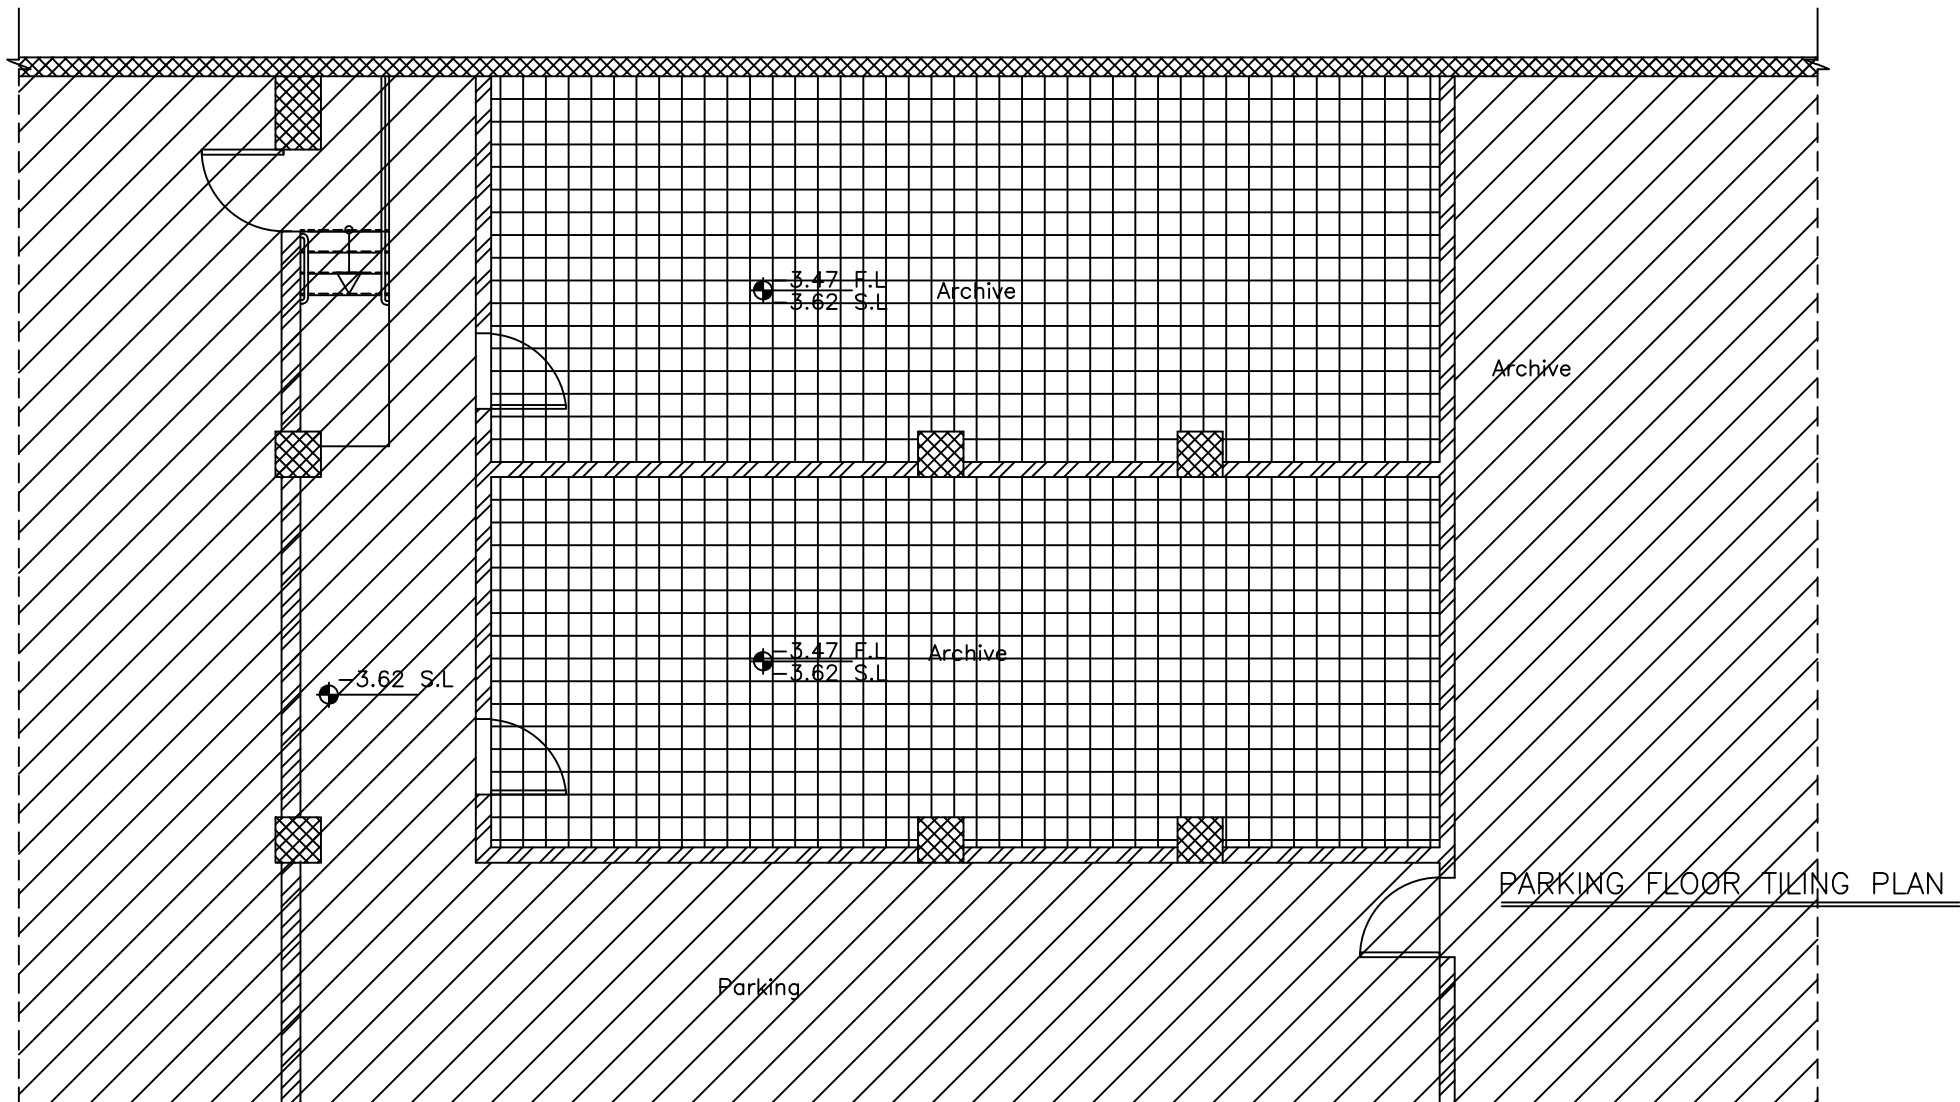

300x300x30MM TERRAZZO



500x250x50MM STONE TILE

NOTES :

- Section/elevation number drawing number.
- Hollow blockwork.
- Reinforced concrete column/wall .
- Reinforced concrete jambs & sills .
- Plain concrete walls.
- Insulated gypsum board partitions.
- F.F.L Finished floor level .
- F.L.L Finished Lintel Level .
- F.S.L Finished Sill Level .
- S.L Slab level .
- S.B.L Slab bottom level.
- F.L Finished level .
- R Radius

EXISTING

REVISION	DATE OF REVISION	INITIALS	REVISION DETAILS



ESTABLISH A SPECIALIZED COURT
IN NABLUS

PROJECT No. :

ISSUE : TENDER


DRAWING : TILING PLANS

	DRAWN : SAFFARINI STAFF	APPROVED: SAFFARINI STAFF	DATE: JUNE, 2021
	NO :	NO. :	
	CHECKED: SAFFARINI STAFF	REF:	SCALE: 1/100
	NO :		

SAFFARINI & ASSOCIATES
Ramallah
Fax 02-2959363
Tel 02-2987675

A25

Rev.: 6

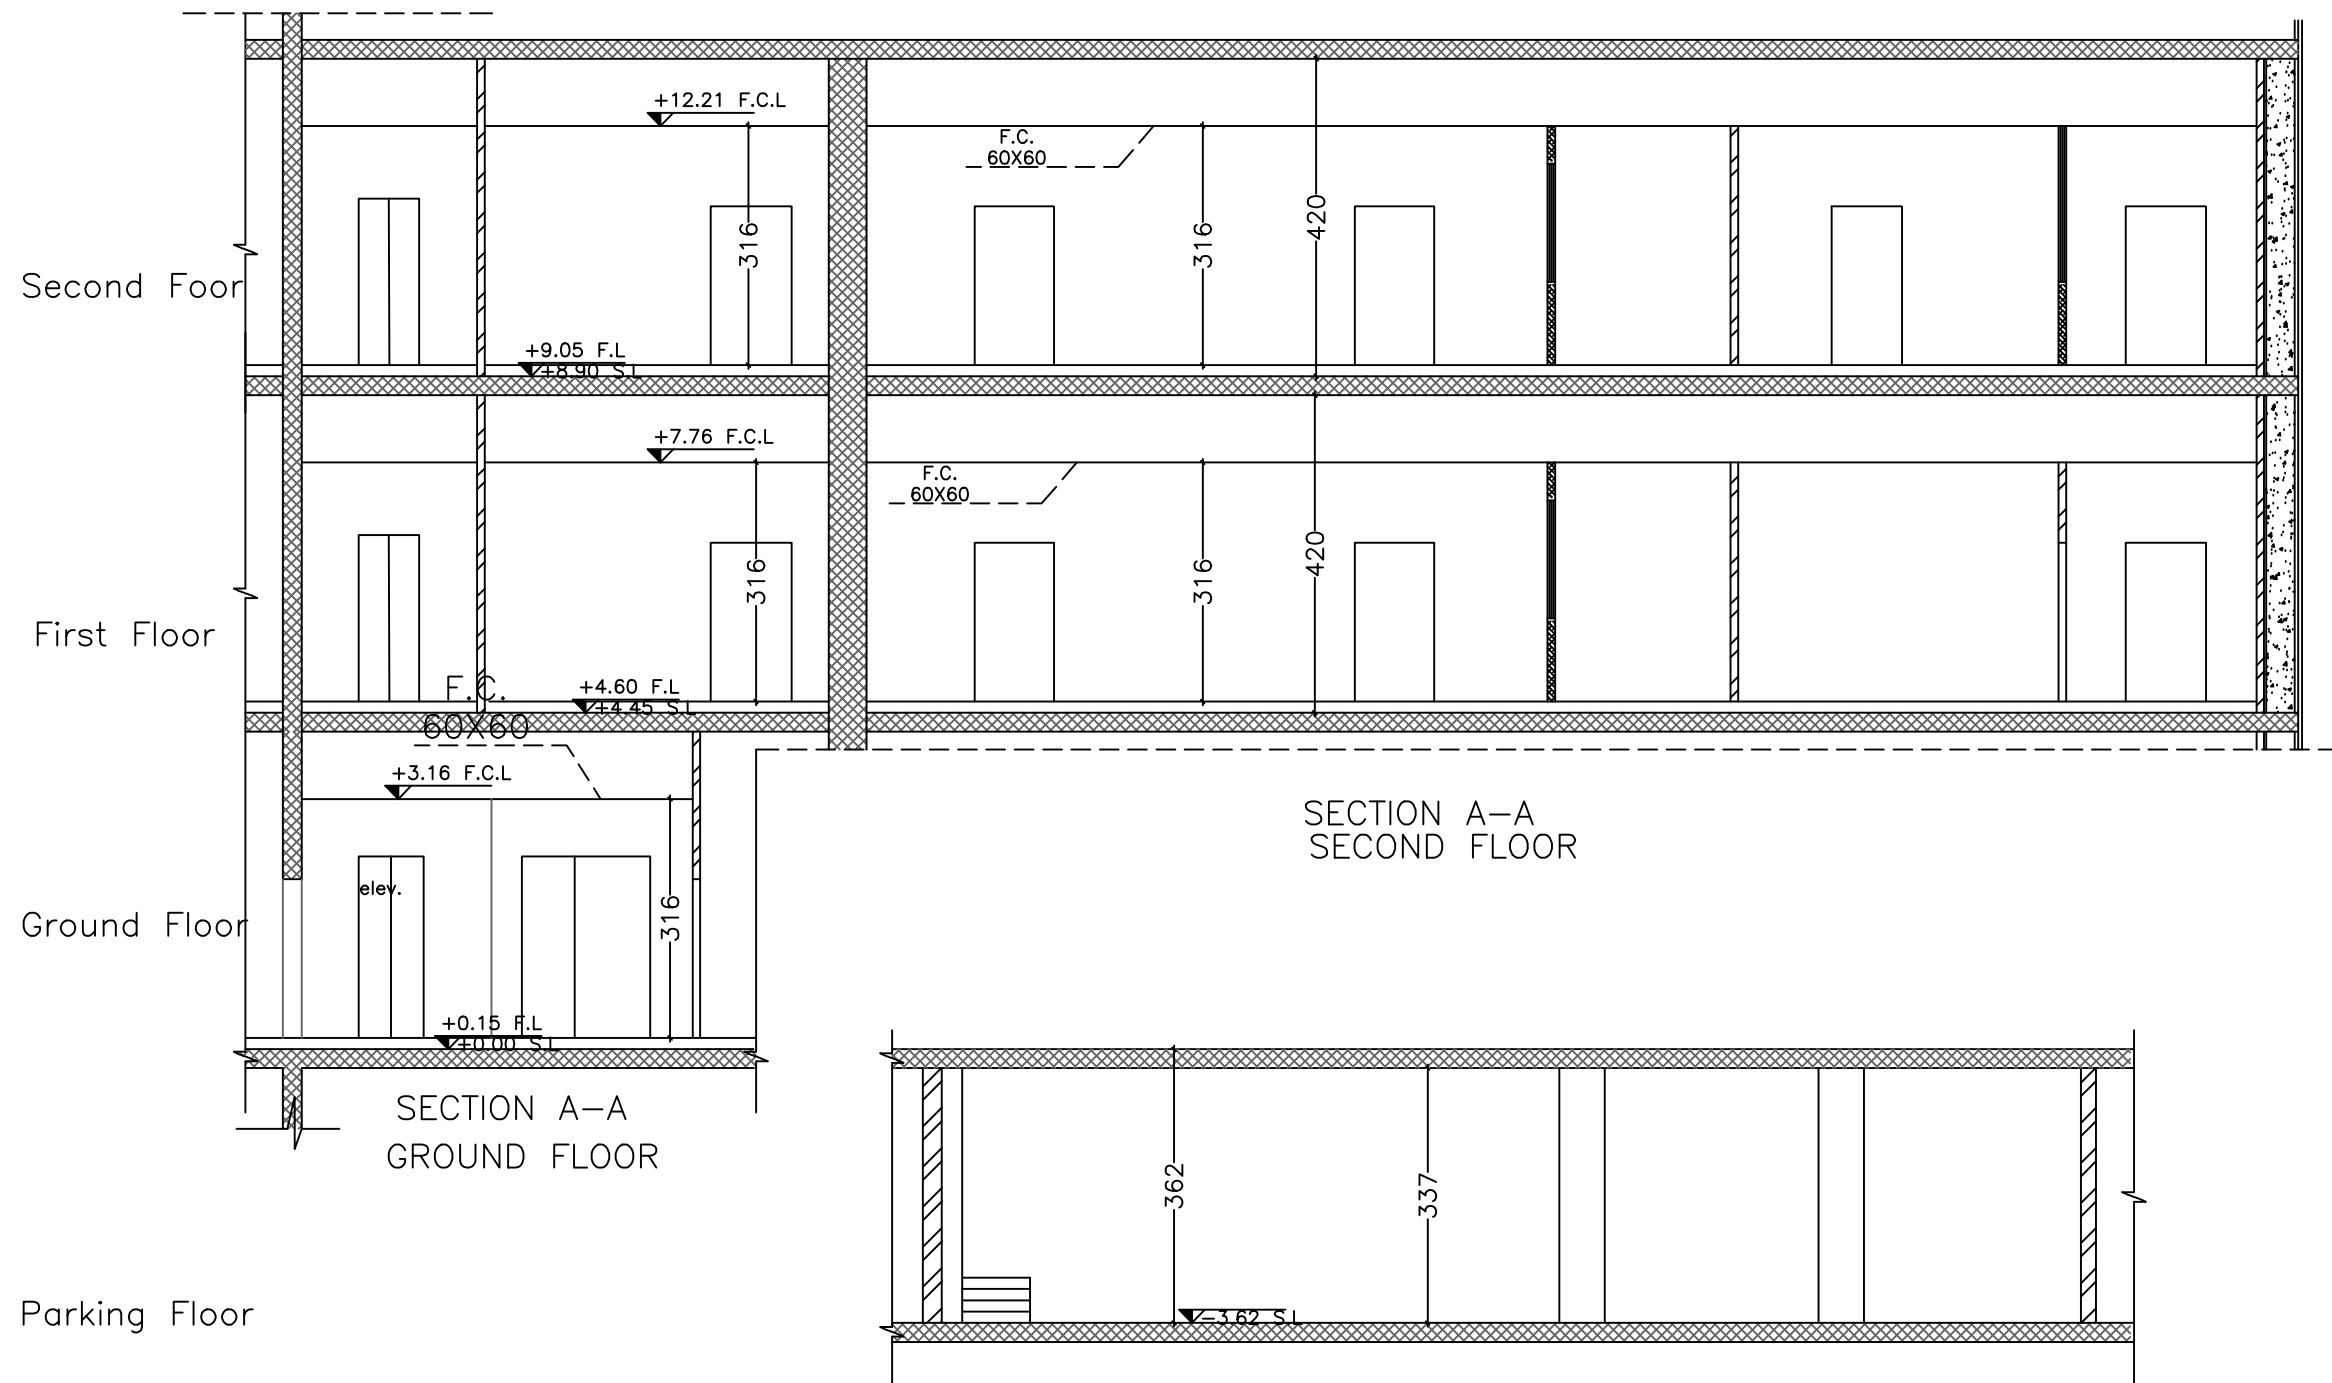

- NOTES :
- Section/elevation number drawing number.
 - Hollow blockwork.
 - Reinforced concrete column/wall .
 - Reinforced concrete jambs & sills .
 - Plain concrete walls.
 - Insulated gypsum board partitions.
 - F.F.L. Finished floor level .
 - F.L.L. Finished Lintel Level .
 - F.S.L. Finished Sill Level .
 - S.L. Slab level .
 - S.B.L. Slab bottom level.
 - F.L. Finished level .
 - R Radius

EXISTING

REVISION	DATE OF REVISION	INITIALS	REVISION DETAILS














ESTABLISH A SPECIALIZED COURT
IN NABLUS

PROJECT No. :	
ISSUE : TENDER	
DRAWING : SECTIONS	
DRAWN : SAFFARINI STAFF NO. :	APPROVED: SAFFARINI STAFF NO. :
CHECKED: SAFFARINI STAFF NO. :	REF:
DATE: JUNE, 2021	SCALE: 1/100

SAFFARINI & ASSOCIATES
Ramallah
Fax 02-2959363
Tel 02-2987675

    A26
Rev.: 6

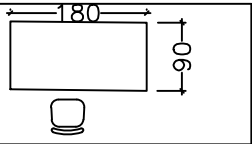1	Judge Disk	
2	Office Drawer Unit	
3	Front Table For Judge Desk T-shaped	
4	Wooden Glass Cabinet For Judge office	
5	Computer Desk For Judge Desk	
6	Side Table For Judge Desk	

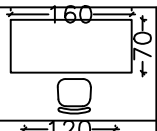     7	Employee Desk	
8	Computer Table For Employee	
9	Wooden File Cabinet with Wooden Shelve For Employee	
10	Glass File Cabinet For Employee	
11	Two Doors Metal Cabinet	
12	metal shelves Each Unit Contains 7 Shelves	

NOTES :

-  Section/elevation number drawing number.
-  Hollow blockwork.
-  Reinforced concrete column/wall .
-  Reinforced concrete jambs & sills .
-  Plain concrete walls.
-  Insulated gypsum board partitions.
-  Finished floor level .
-  Finished Lintel Level .
-  Finished Sill Level .
-  Slab level .
-  Slab bottom level.
-  Finished level .
-  Radius

 EXISTING



ESTABLISH A SPECIALIZED COURT
IN NABLUS

PROJECT No. :

ISSUE : TENDER

DRAWING : FURNITURE SCHEDULE

	DRAWN : SAFFARINI STAFF NO. : CHECKED: SAFFARINI STAFF NO. :	APPROVED: SAFFARINI STAFF NO. : REF:	DATE: JUNE, 2021 SCALE: 1/100
---	---	--	----------------------------------

SAFFARINI & ASSOCIATES
Ramallah
Fax 02-2959363
Tel 02-2987675

A27


Rev.: 6

GRAPHIC SYMBOLS	
	Distribution board
	Low voltage board
	one , two , & three way.
	one , two , & three way weather proof switch
	13A normal power outlet
	13A double normal power outlet
	13A normal power outlet with ip55 modular support frame
	RJ11 2-pair telephone socket
	RJ45 cat7A data socket
	Addressable photo smoke detector
	Addressable heat detector
	Manual call point break glass
	Internal horn and strobe
	Internal horn and strobe with flasher
	Manual call point break glass with internal horn
	Manual call point break glass with internal horn & flasher
	Ceiling mounted loud speaker
	Ceiling surface mounted loud speaker
	Addressable photo smoke detector with flasher
	Sounder with flasher light
	Internal camera
	External camera
	Thermostat (With On-Off Switch)
	Fire Alarm Lamp
	AC Outlet at High Level
	Data Cabinet Box
	30 cm Perforated Cable Tray for Power Lines
	30 cm Mesh Cable Tray for Low Current Lines
	Fireman Switch
	Water Proof Outdoor Socket For Mechanical Units
	Presence or absence detection, microwave Adjustable Ceiling Sensors
	Fireman Telephone
	Wall mounted water proof loud speaker
	Magnetic alarm contact
	Shutter motor
	Shutter switch
	Push button for bell
	Bell horn
	Push button with timer (0-5 min)
	Double pole switch with indicator lamp / w.p.
	3 phase industrial power socket
	Television socket
	Data point in ceiling for wifi
	KNX (smart) push button
	Double UPS Socket

	GENERAL NOTES		
A	THE FOLLOWING NOTES SHALL APPLY TO ALL ELECTRICAL DRAWINGS UNLESS OTHERWISE INDICATED OR NOTED.		
B	DO NOT SCALE FROM THE LAYOUT DRG. WORK ACCORDING TO ARCHITECTURAL AND ELECTRICAL DETAILS UNLESS OTHERWISE INDICATED.		
C	THE ELECTRICAL DRAWINGS SHALL BE READ IN CONJUNCTION WITH THE REST OF THE DRAWINGS PERTAINING TO ARCHITECTURE, STRUCTURE, AIRCONDITIONING, PLUMBING, DECORATION AND THE SPECIFICATIONS AS APPLICABLE.		
D	ALL CONDUITS SHOWN ABOVE FALSE CEILING SHALL BE CONCEALED WHEN RUN IN WALLS BELOW FALSE CEILING.		
E	EARTH CONTINUITY (EQUIPMENT GROUND) CONDUCTORS ARE NEITHER INDICATED ON CONDUITS RUNS, THEY SHALL BE IN ACCORDANCE WITH THE IEE REGULATIONS AND AS INDICATED IN SCHEMATIC DIAGRAMS.		
F	LIGHTING POINTS SHALL BE EXPOSED OR CONCEALED IN CONFORMANCE TO ASSOCIATED CONDUITS.		
G	SHAPE AND DIMENSION OF SYMBOLISED LED LIGHTING FIXTURES ARE NOT NECESSARILY REPRESENT SHAPE AND DIMENSIONS OF ACTUAL FIXTURES INTENDED FOR THIS PURPOSE. (REFER TO LIGHTING FIXTURES SCHEDULE)		
H	LIGHTING SWITCHES NEAR DOORS SHALL BE INSTALLED AT 15CMS.FROM ARCHITRAVE (MEASURED FROM THE EDGE OF THE SWITCH),		
I	LIGHTING FIXTURES MOUNTED IN FALSE CEILING SHALL BE FED THROUGH HEAT RESISTANT WIRES IN METALIC FLEXIBLE CONDUITS CONNECTED TO THE LIGHTING OUTLET BOX.		
J	OUTLET BOX FOR FALSE CEILING MOUNTED LIGHTING FIXTURE SHALL BE POSITIONED SUCH THAT IT WILL NOT BE OBSTRUCTED BY A/C DUCTS, PIPES, ETC. FOR THIS PURPOSE CONTRACTOR SHALL CO-ORDINATE WITH THE A/C AND PLUMBING CONTRACTOR PRIOR TO INSTALLATION.		
K	THE MINIMUM CONDUIT SIZE USED SHALL BE Ø 3/4" min FOR POWER.		
L	FOR GROUP SWITCHING AND WHERE SWITCH BOXES CONTAIN MORE THAN ONE PHASE, APPROVED BARRIER SWITCH BOXES SHALL BE USED WITH A LABEL SHOWING THAT (380V) EXISTS IN THAT BOX.		
M	CONTRACTOR SHALL CO-ORDINATE WITH LOCAL POWER AUTHORITIES AND GET THEIR APPROVAL FOR ELECTRICAL WORKS. REVISIONS (IF NEEDED) SHALL BE WITHOUT EXTRA COST.		
N	CONTRACTOR SHALL BE RESPONSIBLE TO EXECUTE & COMMISSION THE ELECTRICAL WORKS COMPLYING WITH THE LOCAL POWER AUTHORITES REGULATIONS.		
RECOMMENDED HEIGHTS OF WALL MOUNTED FIXTURES *			
REF.	FIXTURES	HEIGHT(mm)	REMARKS
1	LIGHTING SWITCHES	1300	ABOVE F.F.L.
2	NORMAL SOCKET OUTLETS	400	ABOVE F.F.L.
3	A.C. SOCKET OUTLETS	600	BELOW CEILING SLAB
4	DATA AND COMMUNICATION OUTLETS	400	ABOVE F.F.L.
5	INDUSTRIAL SOCKET OUTLETS	300	ABOVE WORKING LEVEL
6	SOCKETS IN MECHANICAL ROOMS	1300	ABOVE F.F.L.
7	HAND DRYER	1400	ABOVE F.F.L.
8	FIRE ALARM BREAK GLASS UNIT	1500	ABOVE F.F.L.
9	TOP OF DISTRIBUTION BOARDS	2000	ABOVE F.F.L.
10	TERMINAL BOXES (LOW CURRENT SYSTEMS WITHIN ELECTRICAL ROOMS OR CLOSETS)	1200-1800	ABOVE F.F.L.
11	KITCHEN SOCKETS	300	ABOVE COUNTER IN KITCHENS
* OTHERS TO BE COORDINATED WITH THE ENGINEER			
RECOMMENDED CONDUITS COLORS PER EACH SYSTEM			
REF.	SYSTEM	COLOR	
1	PUBLIC ADDRESS, CCTV AND BURGLAR ALARM	WHITE	
2	POWER, AC AND BMS SYSTEMS	GREEN	
3	LIGHTING AND KNX SYSTEMS	BLUE	
4	DATA, TELEPHONE AND ACCESS CONTROL	YELLOW	
5	UPS SYSTEM	BROWN	
6	FIRE ALARM SYSTEM	RED	

Drawing No.	Description
	<u>GENERAL:</u>
E-000	LIST OF DRAWINGS, LEGEND & NOTES
	<u>LIGHTING SYSTEM:</u>
E-101	PARKING FLOOR LIGHTING SYSTEM
E-102	GROUND FLOOR LIGHTING SYSTEM
E-103	FIRST FLOOR LIGHTING SYSTEM
E-104	SECOND FLOOR LIGHTING SYSTEM
	<u>POWER & UPS SYSTEMS:</u>
E-201	PARKING FLOOR POWER & UPS SYSTEMS
E-202	FIRST FLOOR POWER & UPS SYSTEMS
E-203	SECOND FLOOR POWER & UPS SYSTEMS
	<u>IT & TELECOMMUNICATION SYSTEMS</u>
E-301	PARKING FLOOR IT SYSTEMS
E-302	FIRST FLOOR IT SYSTEMS
E-303	SECOND FLOOR IT SYSTEMS
	<u>LOW CURRENT SYSTEMS</u>
E-401	PARKING FLOOR LOW CURRENT SYSTEMS
E-402	GROUND FLOOR LOW CURRENT SYSTEMS
E-403	FIRST FLOOR LOW CURRENT SYSTEMS
E-404	SECOND FLOOR LOW CURRENT SYSTEMS
E-405	FM200 SYSTEM DETAILS
E-406	FM200 RISER & NOTES

NOTES :			
REVISION	DATE OF REVISION	INITIALS	REVISION DETAILS
NABLUS SPECIALIZED COURT			
PROJECT No. :			
ISSUE : DESIGN DEVELOPMENT			
DRAWING : List of Drawings, Legend & Notes			
	DRAWN : DIAMOND STAFF	APPROVED: DIAMOND STAFF	DATE: JUNE, 2021
	CHECKED: DIAMOND STAFF		SCALE: 1/100
SAFFARINI & ASSOCIATES Ramallah Fax 02-2959363 Tel 02-2987675			E000 Rev.: 2

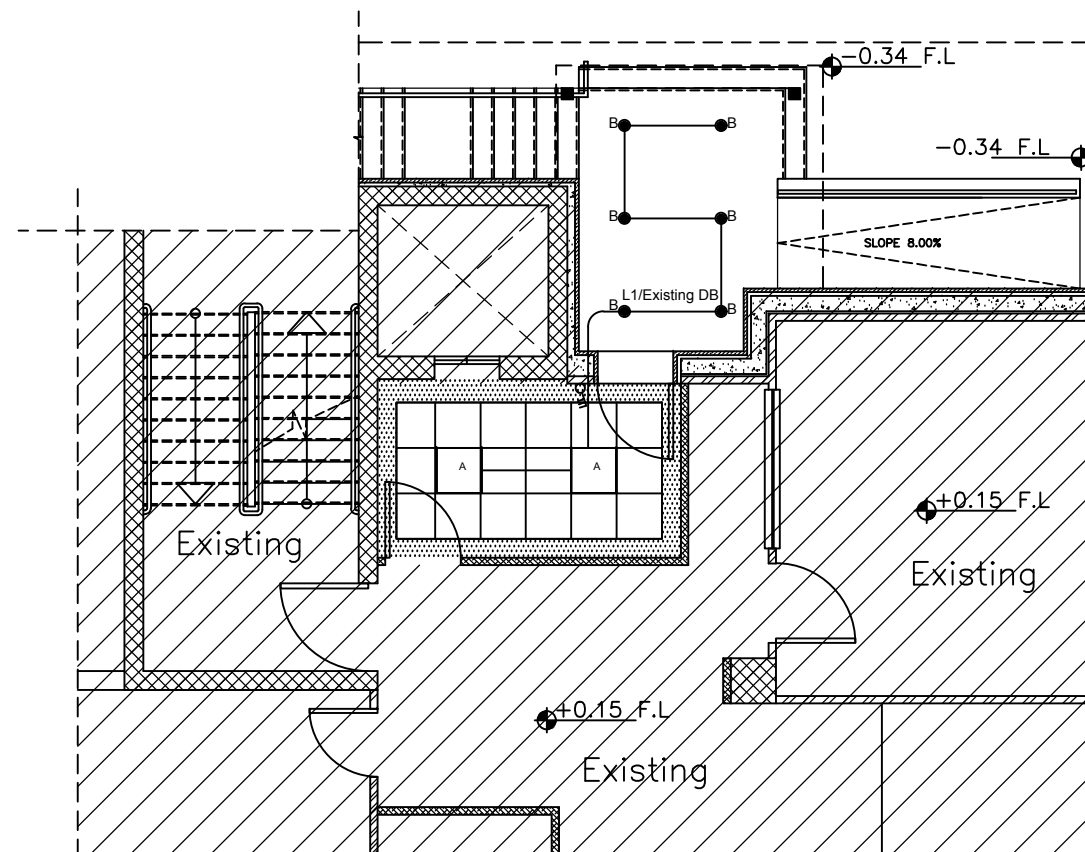

Fixture Type	Fixture Legend	Image	Description	Manufact.	Model	Mech. Impact Protect.	Ingress Protect.	Luminaire Characteristics	Color Temp.	Life Time	Lamp Volts	Dimension	Control Function
A			Recessed LED 60x60 cm aluminum luminaire body, white coated, Body: powder-painted steel sheet Diffuser: opal plexiglass (PLX), Light distribution: rotationally-symmetric color rendering index (CRI) Ra > 80	LUG or equivalent	LUGCLASSIC LED pt	IK07	IP 44	40 W LED 4800 lm	4000 K	50,000 hr. L70 @ 25 °C	230 V	Length x width x Height (800 x 600 x 12) mm	Switchable
B			Recessed LED circular downlight , Material: Bodies made of aluminum with thermo paint coating. Optic: Innovative PMMA optic which provides uniform illumination over the whole surface with a minimum thickness of the luminaire. Index CRI: 80.	Secom or equivalent	Aircorn Circular	-----	IP 44	20 W LED 2677 lm	4000 K	50,000 hr.	230 V	Overall Diameter x Height (245 x 50) mm	Switchable
Em			Circular recessed ceiling mounted, high-brightness, white led light source. Function: standalone. Optic: Asymmetrical, 1 LED. Body color: white.	Eaton Lincry or equivalent	-----	-----	IP42	4.4 W LED 300 lm	6000 K		230 V		

Fixture Notes :

1. All light fixture ballast/drivers shall be electronic type 10% total harmonic distribution maximum.
2. All LED Light modules shall be 80 CRI minimum.
3. All LED Drivers shall have manufacturer's certification compliance

NOTES :

- 1- Wiring shall be carried out using N2XY 3x1.5 mm2 cable unless otherwise indicated
- 2- All exit signs shall be connected at the same circuit separated from lighting circuits

REVISION	DATE OF REVISION	INITIALS	REVISION DETAILS

NABLUS SPECIALIZED COURT

PROJECT No. :

ISSUE : DESIGN DEVELOPMENT

DRAWING : Ground Floor Lighting

	DRAWN : DIAMOND STAFF	APPROVED: DIAMOND STAFF	DATE: JUNE, 2021
	CHECKED: DIAMOND STAFF		SCALE: 1/100


SAFFARINI & ASSOCIATES
Ramallah
Fax 02-2959363
Tel 02-2987675

E102

Rev.: 2

FIXTURE TYPE	FIXTURE LEGEND	IMAGE	DESCRIPTION	MANUFACT.	MODEL	MECH. IMPACT PROTECT.	INGRESS PROTECT.	LUMINAIRE CHARACTERISTICS	COLOR TEMP.	LIFE TIME	LAMP VOLTS	DIMENSION	CONTROL FUNCTION
A			Recessed LED 60x60 cm aluminum luminaire body, white coated, Body: powder-painted steel sheet Diffuser: opal plexiglass (PLX), Light distribution: rotationally-symmetric color rendering index (CRI) Ra > 80	LUG or equivalent	LUGCLASSIC LED pt	IK07	IP 44	40 W LED 4800 lm	4000 K	50,000 hr. L70 @ 25 °C	230 V	Length x width x Height (600 x 600 x 12) mm	Switchable
B			Recessed LED circular downlight . Material: Bodies made of aluminum with thermo paint coating. Optics: Innovative PMMA optic which provides uniform illumination over the whole surface with a minimum thickness of the luminaire. Index CRI: 80.	Secom or equivalent	Aircorn Circular	---	IP 44	20 W LED 2677 lm	4000 K	50,000 hr.	230 V	Overall Diameter x Height (245 x 50) mm	Switchable
Em			Circular recessed ceiling mounted, high-brightness, white led light source. Function: standalone. Optic: Asymmetrical, 1 LED. Body color: white.	Eaton Linergy or equivalent	---	---	IP42	4.4 W LED 300 lm	6000 K		230 V		

- Fixture Notes :
1. All light fixture ballast/drivers shall be electronic type 10% total harmonic distribution maximum.
 2. All LED Light modules shall be 80 CRI minimum.
 3. All LED Drivers shall have manufactr's certification compliance

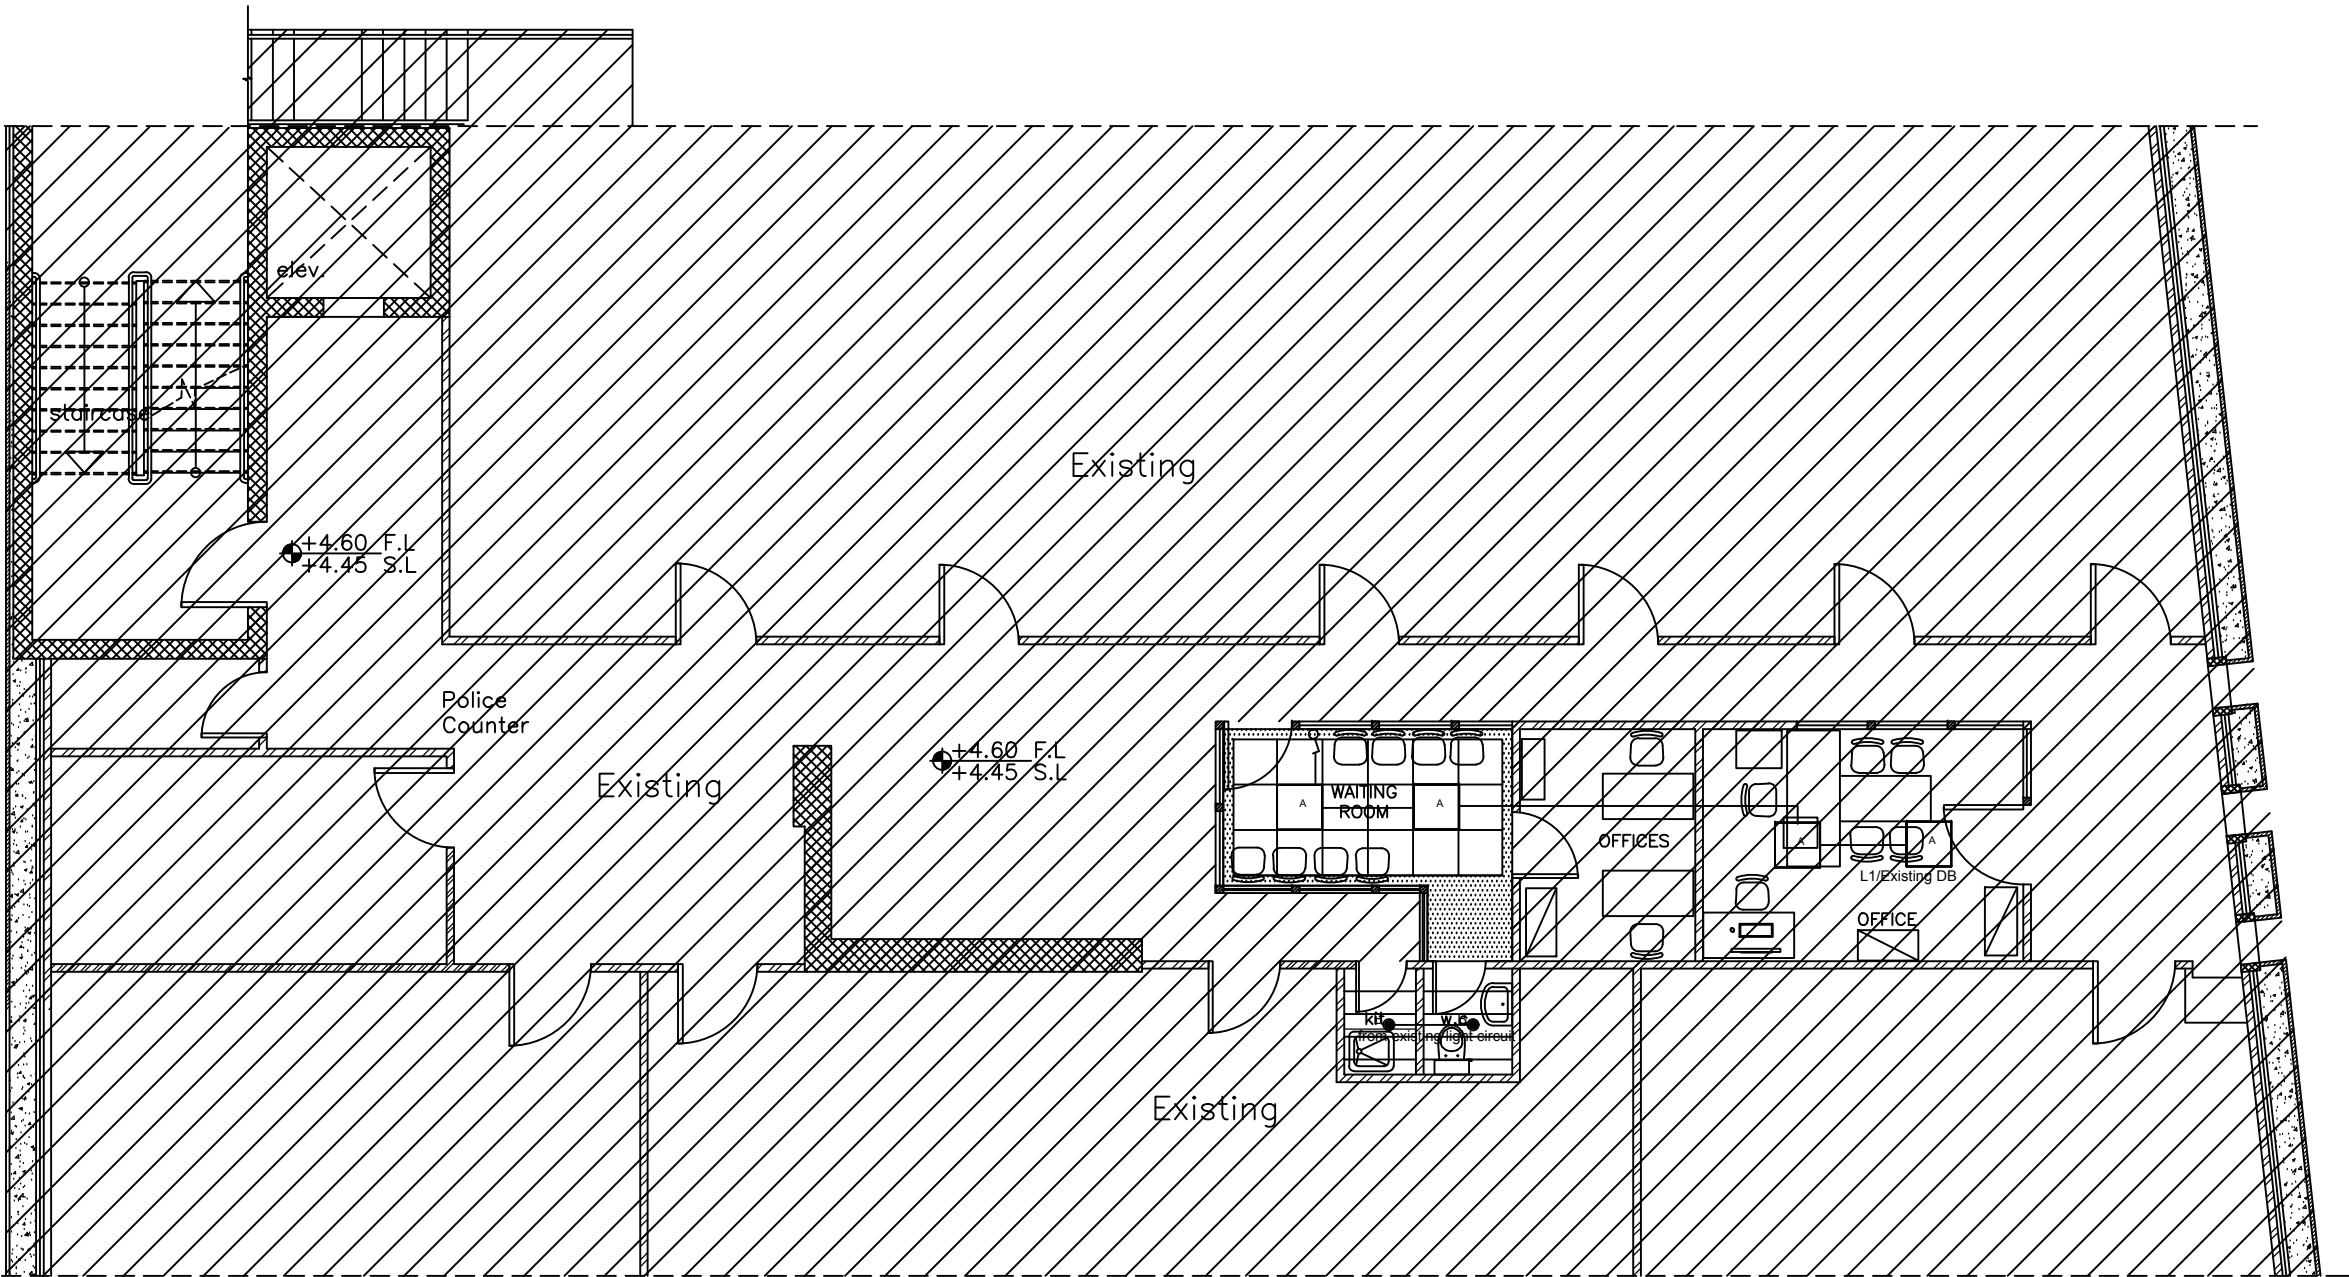

NOTES :

- 1- Wiring shall be carried out using N2XY 3x1.5 mm2 cable unless otherwise indicated
- 2- All exit signs shall be connected at the same circuit separated from lighting circuits

REVISION	DATE OF REVISION	INITIALS	REVISION DETAILS

NABLUS SPECIALIZED COURT


PROJECT No. :			
ISSUE : DESIGN DEVELOPMENT			
DRAWING : First Floor Lighting			
	DRAWN : DIAMOND STAFF	APPROVED: DIAMOND STAFF	DATE: JUNE, 2021
	CHECKED: DIAMOND STAFF		SCALE: 1/100

SAFFARINI & ASSOCIATES
Ramallah
Fax 02-2959363
Tel 02-2987675

E103
Rev.: 2

FIXTURE TYPE	FIXTURE LEGEND	IMAGE	DESCRIPTION	MANUFACT.	MODEL	MECH. IMPACT PROTECT.	INGRESS PROTECT.	LUMINAIRE CHARACTERISTICS	COLOR TEMP.	LIFE TIME	LAMP VOLTS	DIMENSION	CONTROL FUNCTION
A			Recessed LED 60x60 cm aluminum luminaire body, white coated, Body: powder-painted steel sheet Diffuser: opal plexiglass (PLX), Light distribution: rotationally-symmetric color rendering index (CRI) Ra > 80	LUG or equivalent	LUGCLASSIC LED p/t	IK07	IP 44	40 W LED 4800 lm	4000 K	50,000 hr. L70 @ 25 °C	230 V	Length x width x Height (600 x 600 x 12) mm	Switchable
B			Recessed LED circular downlight , Material: Bodies made of aluminum with thermo paint coating. Optics: Innovative PMMA optic which provides uniform illumination over the whole surface with a minimum thickness of the luminaire. Index CRI: 80.	Secom or equivalent	Aircom Circular	-----	IP 44	20 W LED 2677 lm	4000 K	50,000 hr.	230 V	Overall Diameter x Height (245 x 50) mm	Switchable
Em			Circular recessed ceiling mounted, high-brightness, white led light source. Function: standalone. Optic: Asymmetrical, 1 LED. Body color: white.	Eaton Linergy or equivalent	-----	-----	IP42	4.4 W LED 300 lm	6000 K		230 V		

Fixture Notes :
1. All light fixture ballast/drivers shall be electronic type 10% total harmonic distribution maximum.
2. All LED Light modules shall be 80 CRI minimum.
3. All LED Drivers shall have manufactrer's certification compliance

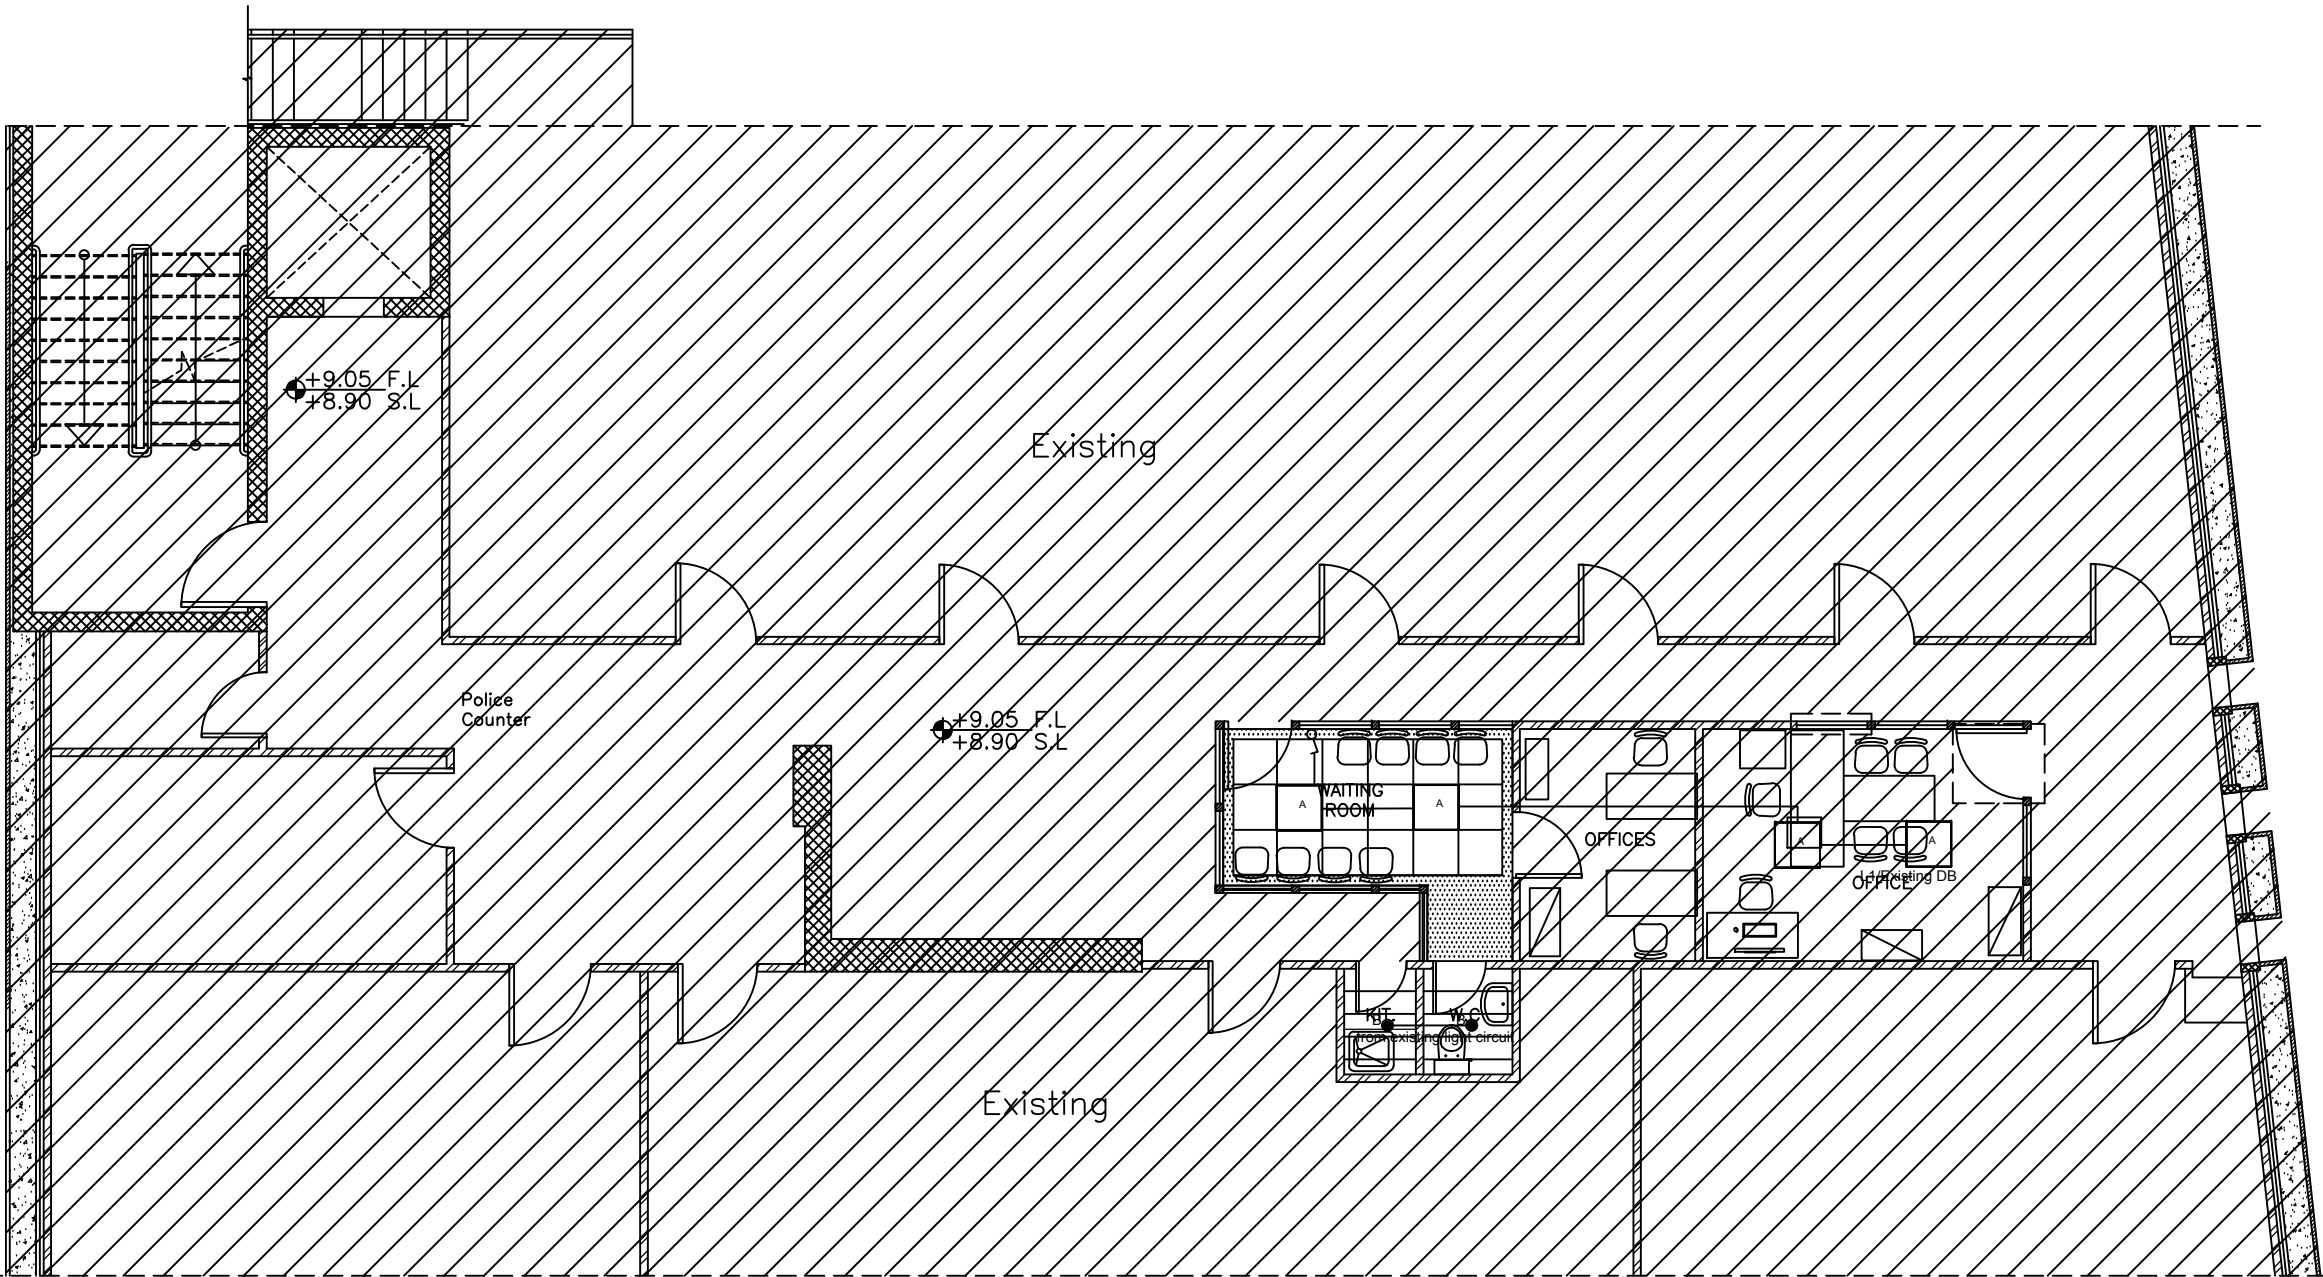


NOTES :

- 1- Wiring shall be carried out using N2XY 3x1.5 mm2 cable unless otherwise indicated
- 2- All exit signs shall be connected at the same circuit separated from lighting circuits

REVISION	DATE OF REVISION	INITIALS	REVISION DETAILS

NABLUS SPECIALIZED COURT

PROJECT No. :			
ISSUE : DESIGN DEVELOPMENT			
DRAWING : Second floor Lighting			
	DRAWN : DIAMOND STAFF	APPROVED: DIAMOND STAFF	DATE: JUNE, 2021
	CHECKED: DIAMOND STAFF		SCALE: 1/100
SAFFARINI & ASSOCIATES Ramallah Fax 02-2959363 Tel 02-2987675			E104 Rev.: 2

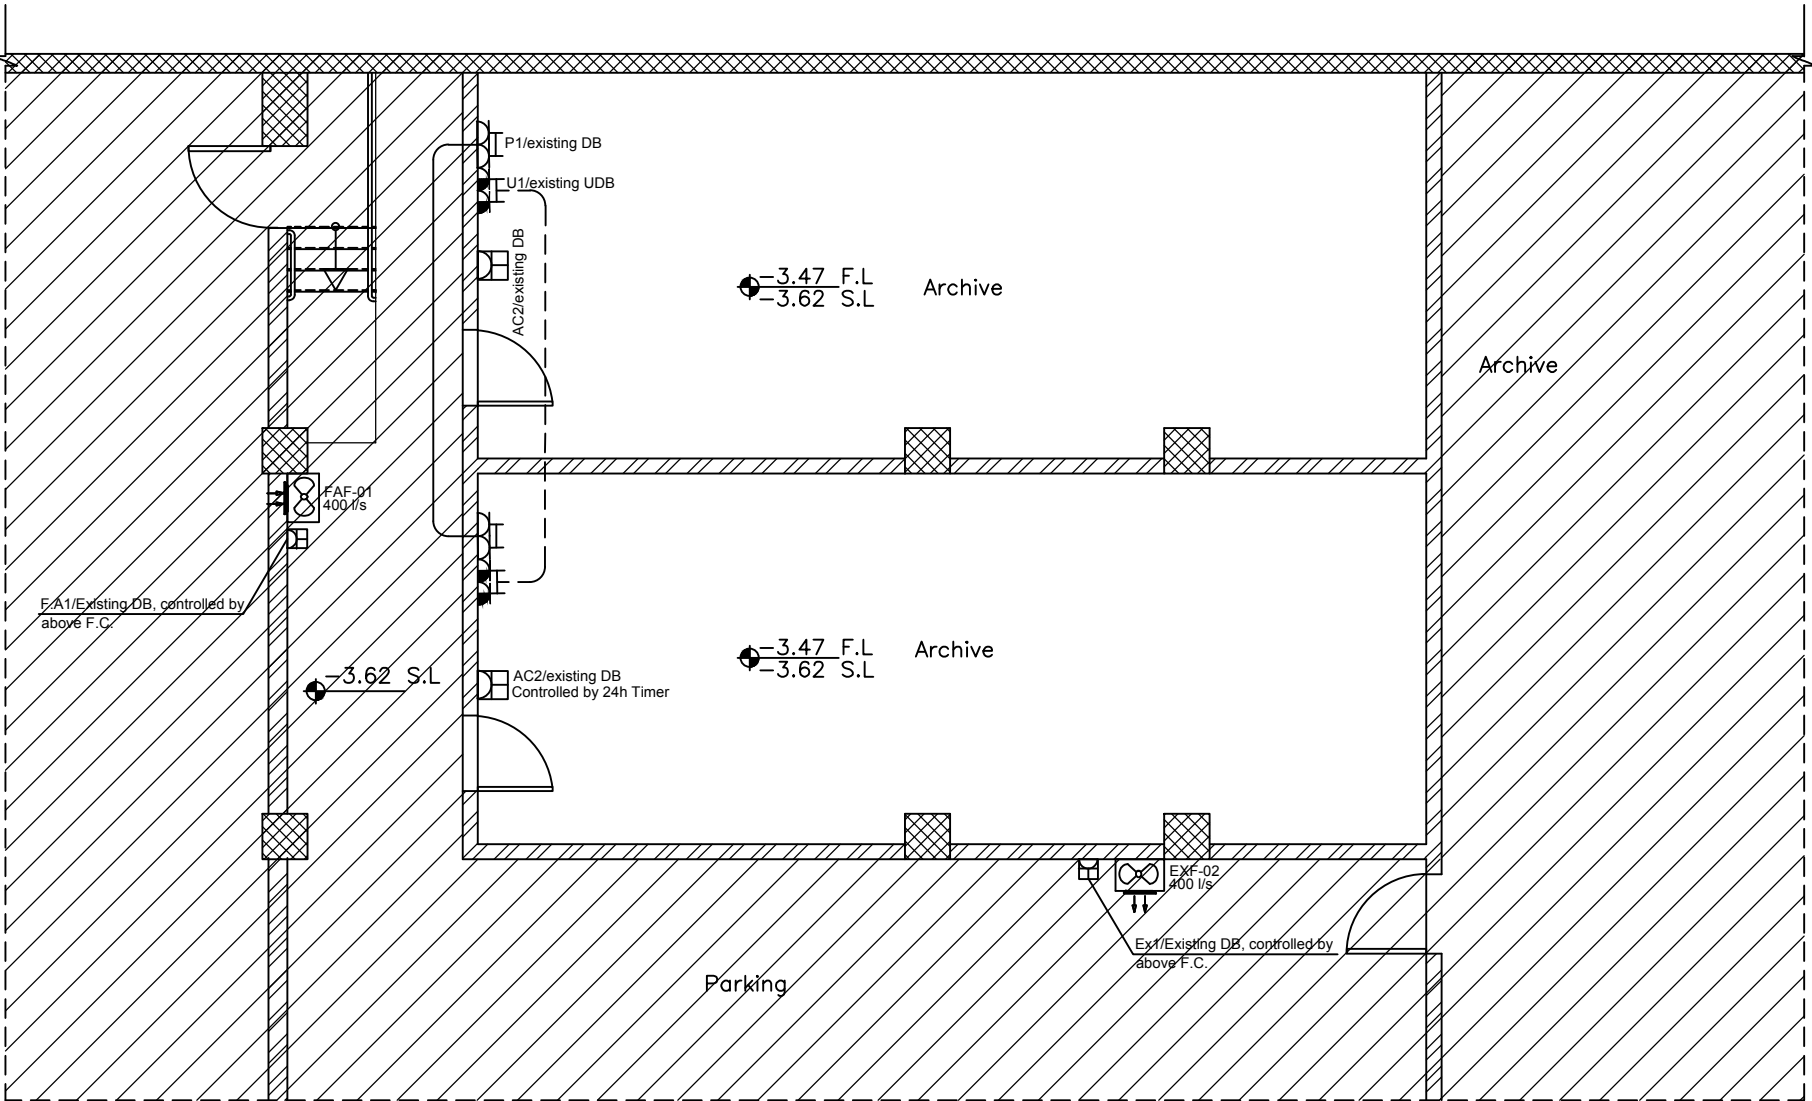

NOTES :

- 1- Wiring shall be carried out using N2XY 3x2.5 mm2 cable unless otherwise indicated
- 2- Height for all sockets = 40 cm F.F.L. unless otherwise mentioned.

POWER SYSTEM	
	DISTRIBUTION BOARD
	NORMAL POWER OUTLET
	SINGLE UPS POWER OUTLET
	DOUBLE UPS POWER OUTLET
	FOURTH UPS POWER OUTLET
	DOUBLE NORMAL POWER OUTLET
	NORMAL POWER OUTLET WITH IP55 MODULAR SUPPORT FRAME
	AC Outlet at High Level
	Thermostat (With On-Off Switch)
	HDMI socket


REVISION	DATE OF REVISION	INITIALS	REVISION DETAILS

NABLUS SPECIALIZED COURT

PROJECT No. :			
ISSUE : DESIGN DEVELOPMENT			
DRAWING : Parking Floor Power & UPS			
	DRAWN : DIAMOND STAFF	APPROVED: DIAMOND STAFF	DATE: JUNE, 2021
	CHECKED: DIAMOND STAFF		SCALE: 1/100

SAFFARINI & ASSOCIATES
Ramallah
Fax 02-2959363
Tel 02-2987675

E201
Rev.: 2

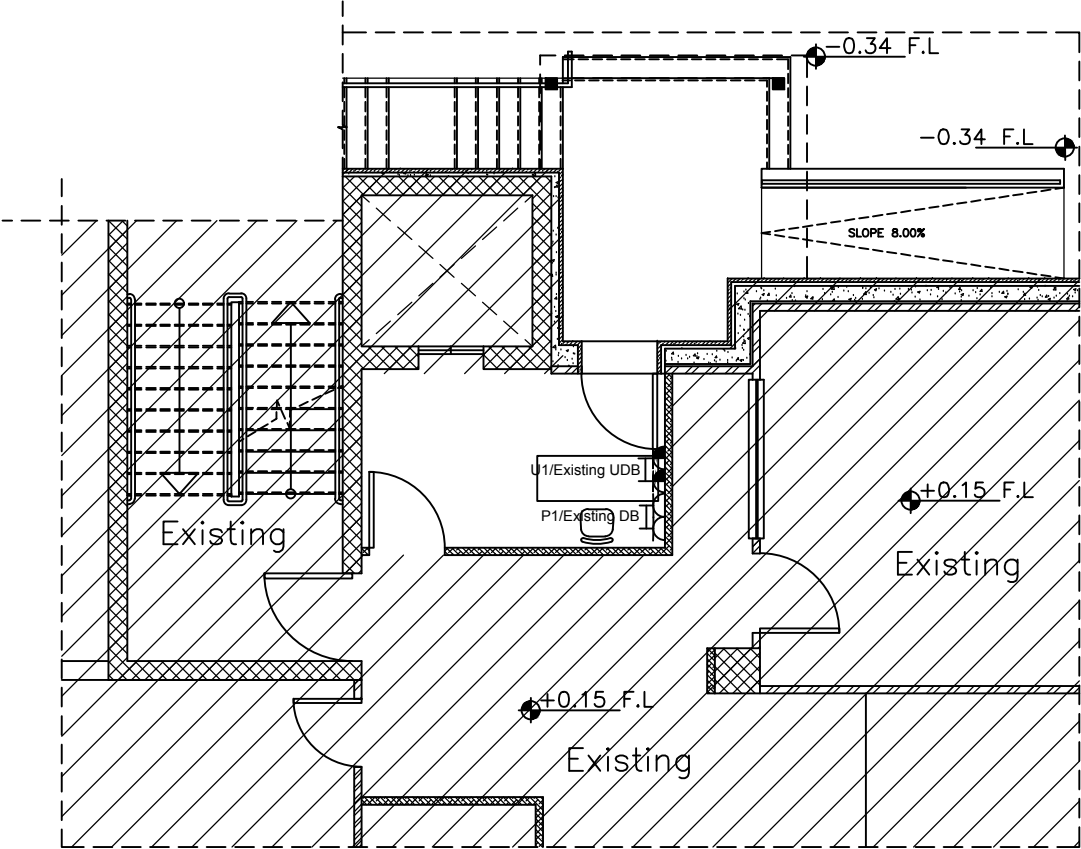

NOTES :

- 1- Wiring shall be carried out using N2XY 3x2.5 mm2 cable unless otherwise indicated
- 2- Height for all sockets = 40 cm F.F.L. unless otherwise mentioned.

POWER SYSTEM	
	DISTRIBUTION BOARD
	NORMAL POWER OUTLET
	SINGLE UPS POWER OUTLET
	DOUBLE UPS POWER OUTLET
	FOURTH UPS POWER OUTLET
	DOUBLE NORMAL POWER OUTLET
	NORMAL POWER OUTLET WITH IP55 MODULAR SUPPORT FRAME
	AC Outlet at High Level
	Thermostat (With On-Off Switch)
	HDMI socket


REVISION	DATE OF REVISION	INITIALS	REVISION DETAILS

NABLUS SPECIALIZED COURT

PROJECT No. :			
ISSUE : DESIGN DEVELOPMENT			
DRAWING : Parking Floor Power & UPS			
	DRAWN : DIAMOND STAFF	APPROVED: DIAMOND STAFF	DATE: JUNE, 2021
	CHECKED: DIAMOND STAFF		SCALE: 1/100

SAFFARINI & ASSOCIATES
Ramallah
Fax 02-2959363
Tel 02-2987675

E201
Rev.: 2

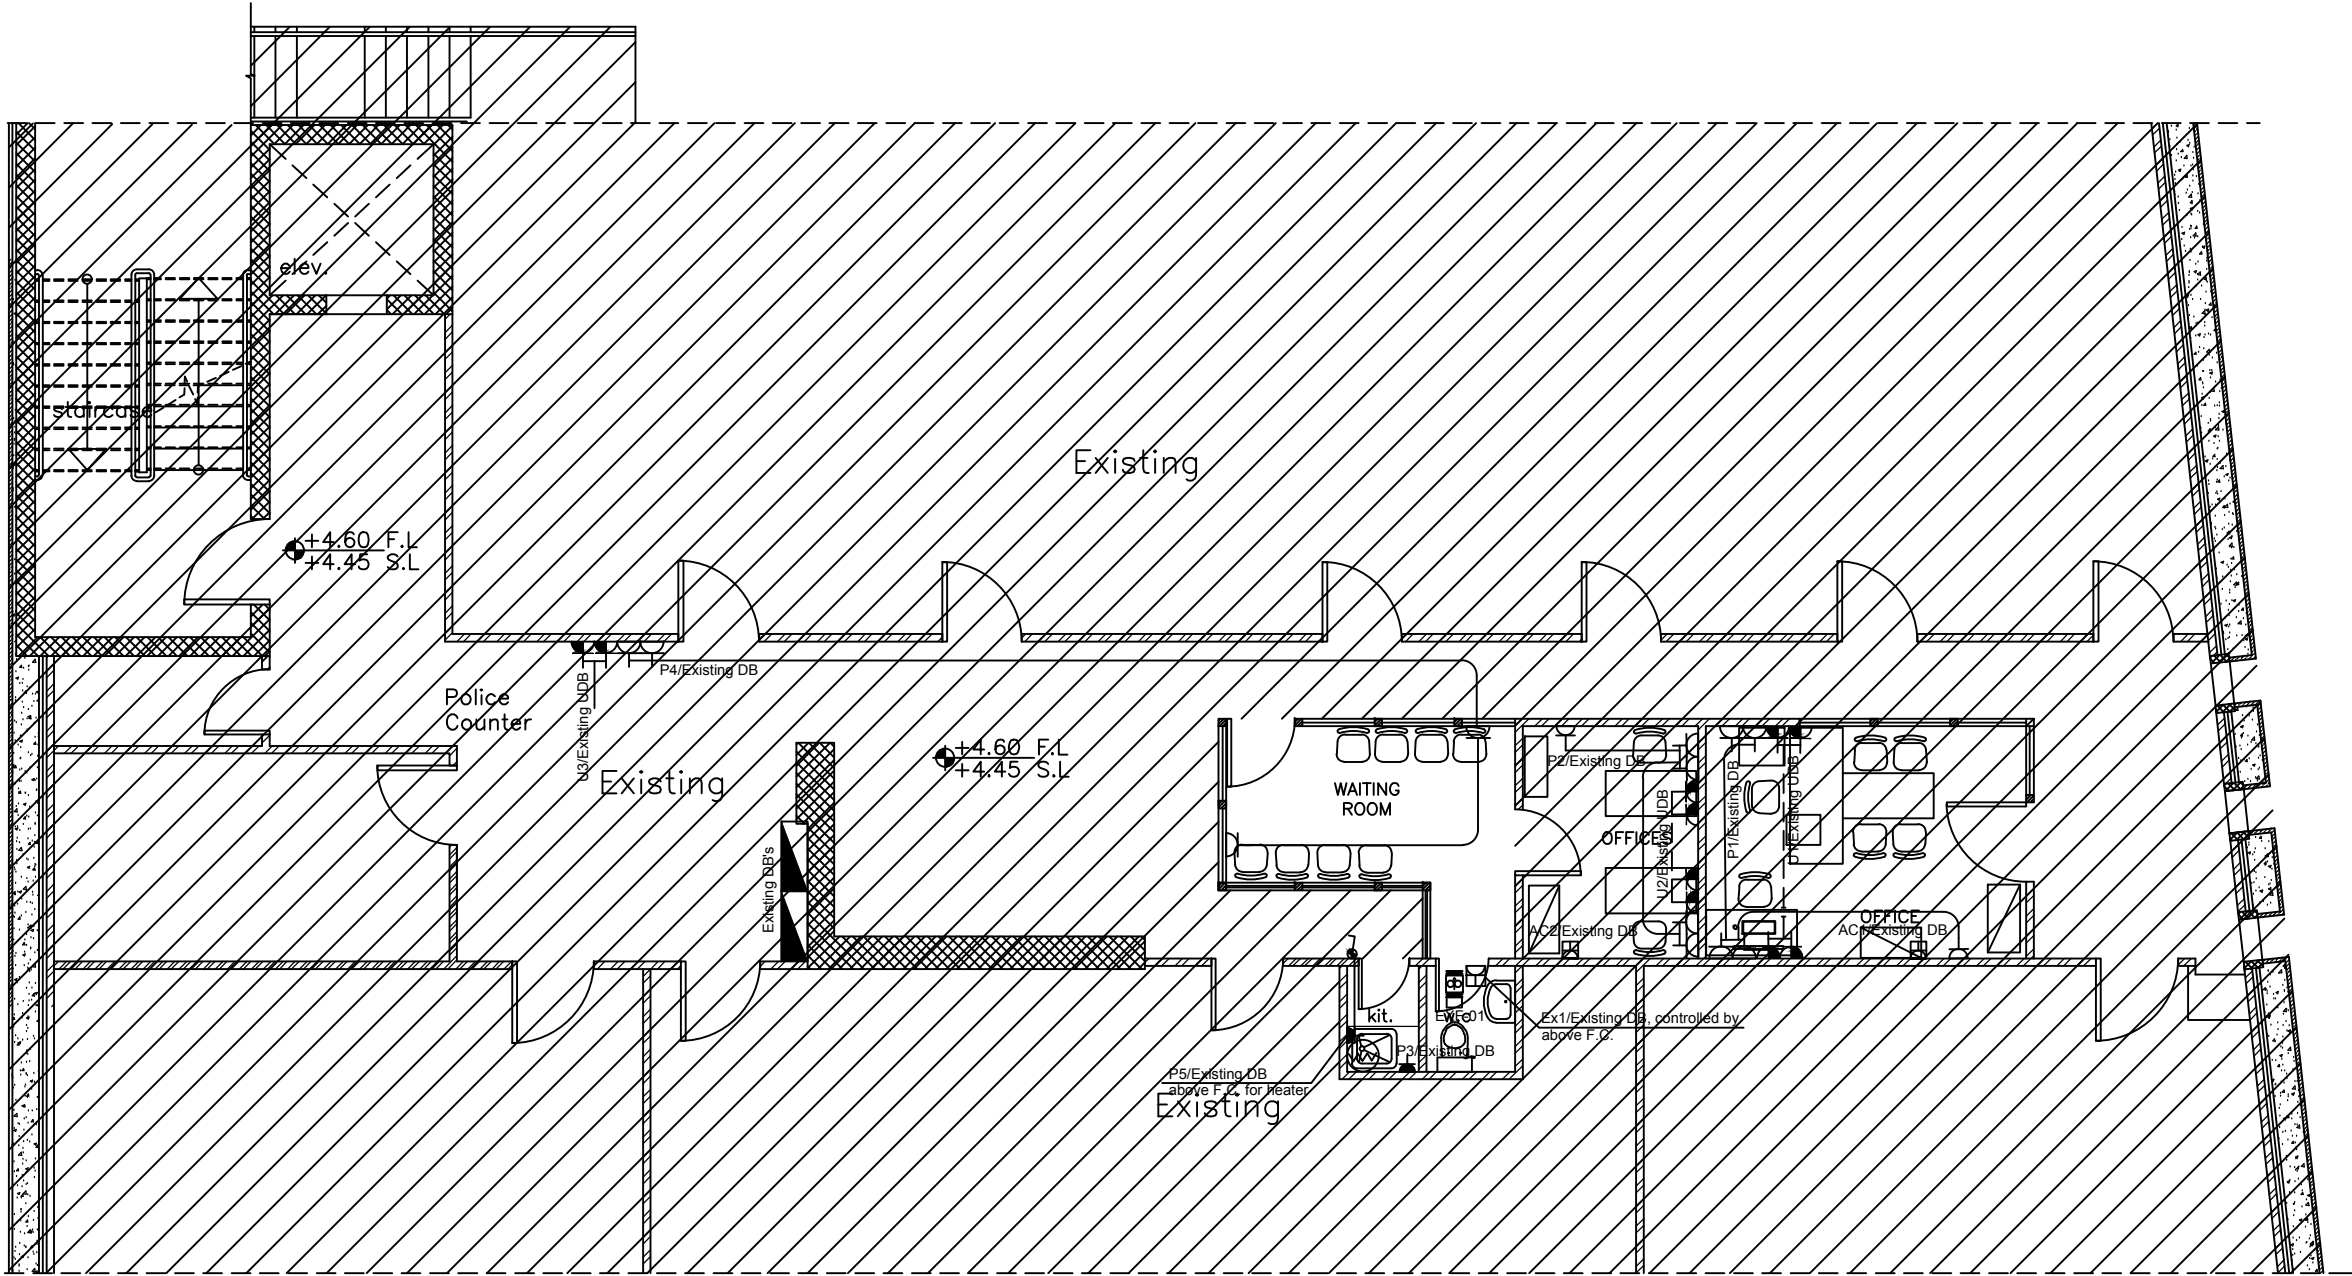


NOTES :

- 1- Wiring shall be carried out using N2XY 3x2.5 mm2 cable unless otherwise indicated
- 2- Height for all sockets = 40 cm F.F.L. unless otherwise mentioned.

POWER SYSTEM	
	DISTRIBUTION BOARD
	NORMAL POWER OUTLET
	SINGLE UPS POWER OUTLET
	DOUBLE UPS POWER OUTLET
	FOURTH UPS POWER OUTLET
	DOUBLE NORMAL POWER OUTLET
	NORMAL POWER OUTLET WITH IP55 MODULAR SUPPORT FRAME
	AC Outlet at High Level
	Thermostat (With On-Off Switch)
	HDMI socket

REVISION	DATE OF REVISION	INITIALS	REVISION DETAILS
NABLUS SPECIALIZED COURT			
PROJECT No. :			
ISSUE : DESIGN DEVELOPMENT			
DRAWING : First Floor Power & UPS			
	DRAWN : DIAMOND STAFF	APPROVED: DIAMOND STAFF	DATE: JUNE, 2021
	CHECKED: DIAMOND STAFF		SCALE: 1/100
SAFFARINI & ASSOCIATES Ramallah Fax 02-2959363 Tel 02-2987675			E203 Rev.: 2

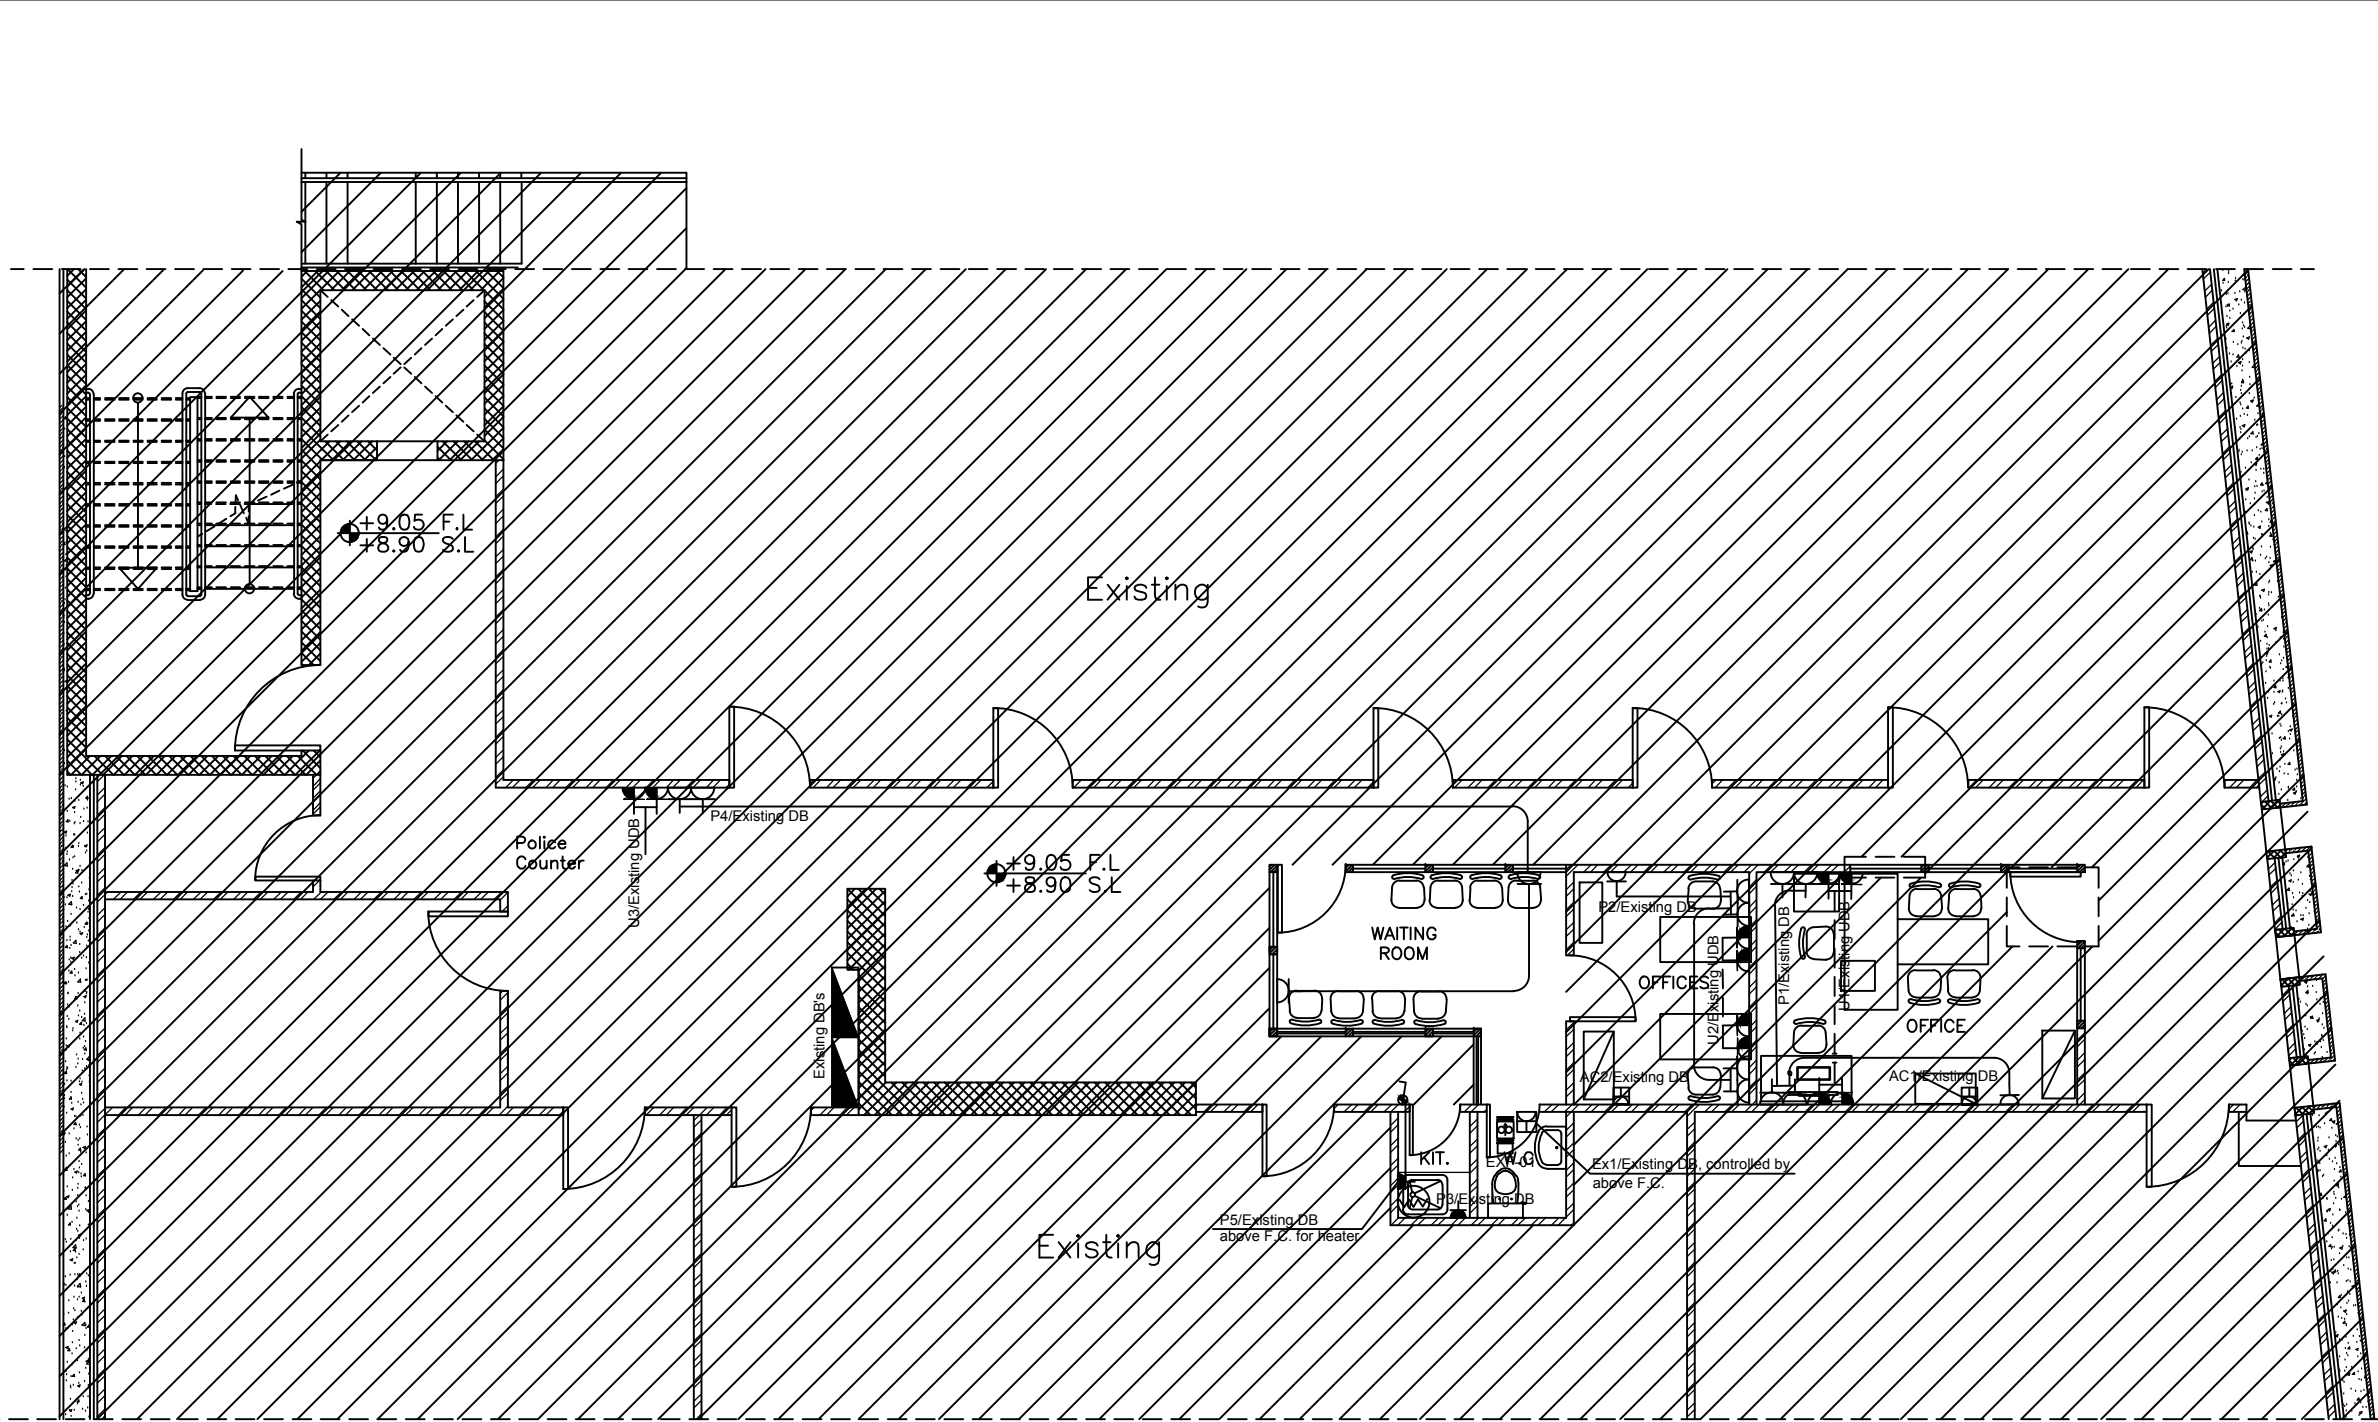


NOTES :

- 1- Wiring shall be carried out using N2XY 3x2.5 mm2 cable unless otherwise indicated
- 2- Height for all sockets = 40 cm F.F.L. unless otherwise mentioned.

POWER SYSTEM	
	DISTRIBUTION BOARD
	NORMAL POWER OUTLET
	SINGLE UPS POWER OUTLET
	DOUBLE UPS POWER OUTLET
	FOURTH UPS POWER OUTLET
	DOUBLE NORMAL POWER OUTLET
	NORMAL POWER OUTLET WITH IP55 MODULAR SUPPORT FRAME
	AC Outlet at High Level
	Thermostat (With On-Off Switch)
	HDMI socket

REVISION	DATE OF REVISION	INITIALS	REVISION DETAILS
NABLUS SPECIALIZED COURT			
PROJECT No. :			
ISSUE : DESIGN DEVELOPMENT			
DRAWING : Second floor Power & U			
	DRAWN : DIAMOND STAFF	APPROVED: DIAMOND STAFF	DATE: JUNE, 2021
	CHECKED: DIAMOND STAFF		SCALE: 1/100
SAFFARINI & ASSOCIATES Ramallah Fax 02-2959363 Tel 02-2987675			E204 Rev.: 2

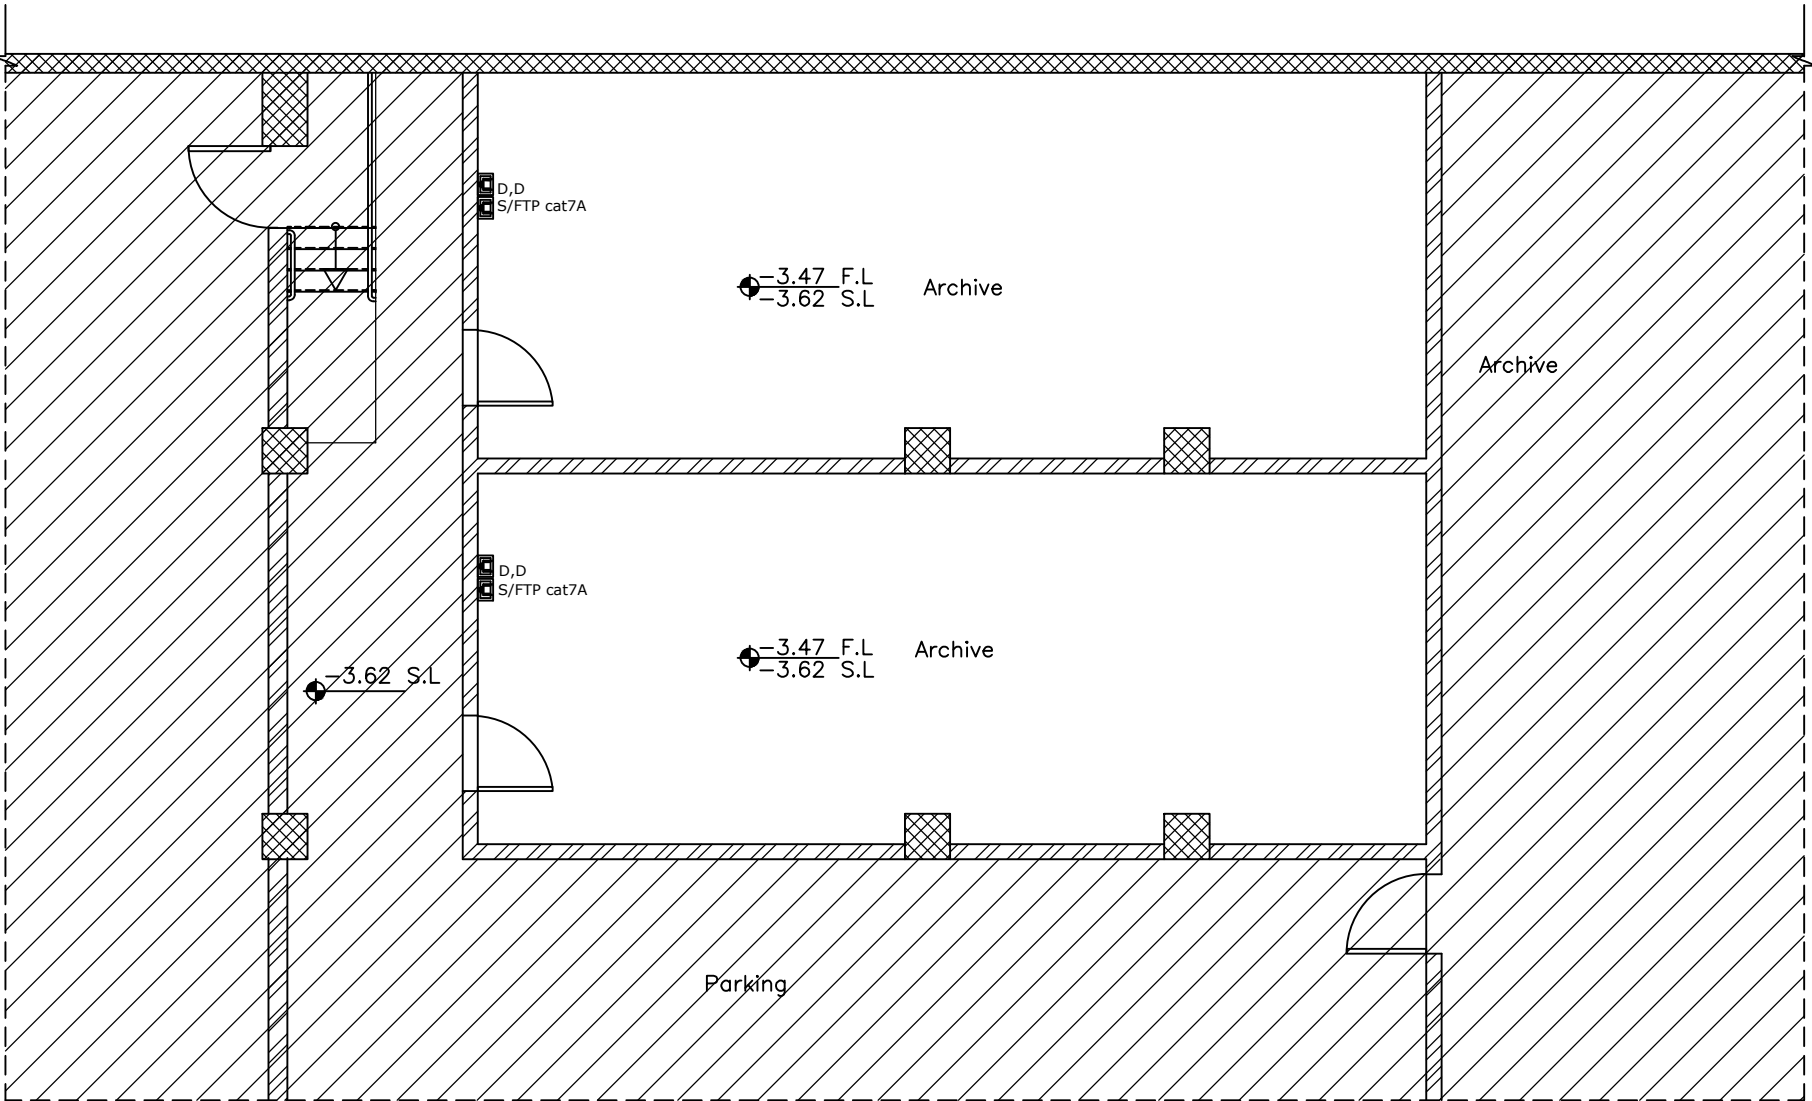

NOTES :

- 1- S/FTP cat7A shall be installed for each Data and voice outlets connected back to existing data cabinet.
- 2- Height for all sockets = 40 cm F.F.L. unless otherwise mentioned.
- 3- D: Data Outlet, V: Voice Outlet

IT & TELECOMMUNICATION SYSTEMS	
▼	RJ45 CAT 7A TELEPHONE SOCKET
■	RJ45 CAT 7 A DATA SOCKET
■	DATA CABINET BOX
■	30cm CABLE LADDER

REVISION	DATE OF REVISION	INITIALS	REVISION DETAILS
----------	------------------	----------	------------------


NABLUS SPECIALIZED COURT

PROJECT No. :			
ISSUE : DESIGN DEVELOPMENT			
DRAWING : Parking Floor IT Systems			
⊕	DRAWN : DIAMOND STAFF	APPROVED: DIAMOND STAFF	DATE: JUNE, 2021
	CHECKED: DIAMOND STAFF		SCALE: 1/100

SAFFARINI & ASSOCIATES
Ramallah
Fax 02-2959363
Tel 02-2987675

E301

Rev.: 2

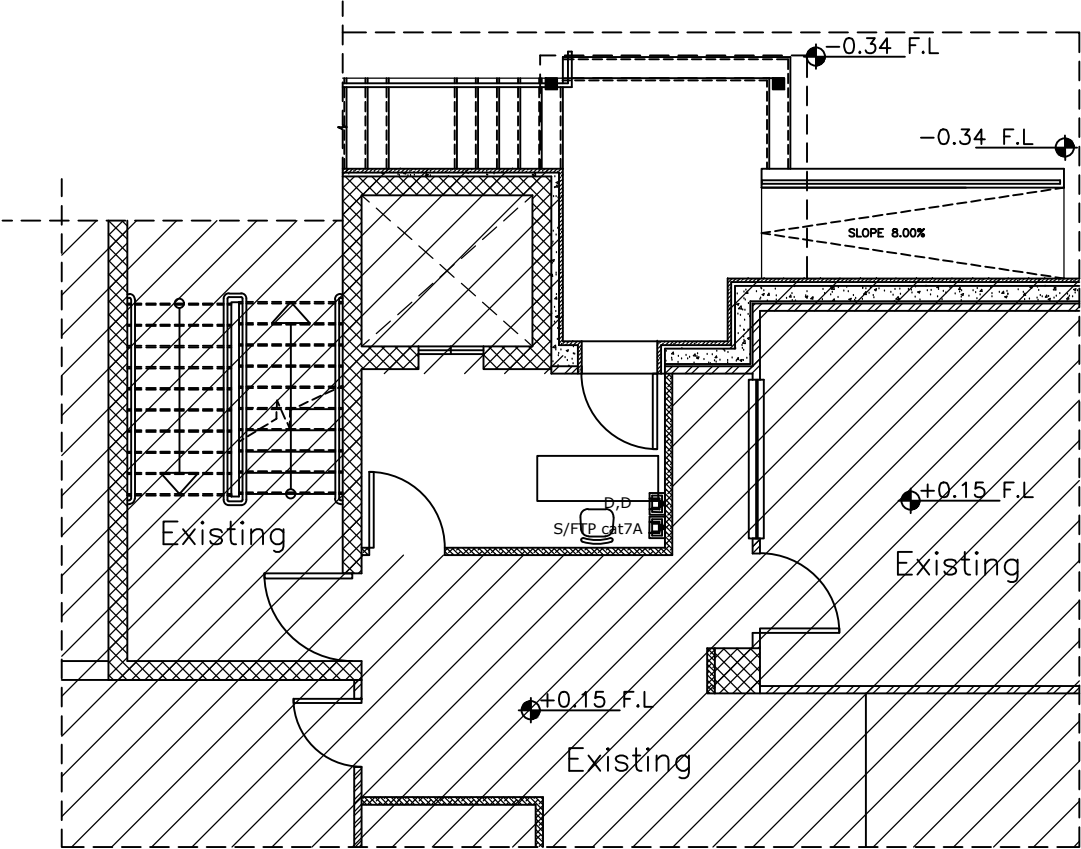


NOTES :

- 1- S/FTP cat7A shall be installed for each Data and voice outlets connected back to existing data cabinet.
- 2- Height for all sockets = 40 cm F.F.L. unless otherwise mentioned.
- 3- D: Data Outlet, V: Voice Outlet

IT & TELECOMMUNICATION SYSTEMS	
▼	RJ45 CAT 7A TELEPHONE SOCKET
⌚	RJ45 CAT 7 A DATA SOCKET
⌚	DATA CABINET BOX
⌚	30cm CABLE LADDER

REVISION	DATE OF REVISION	INITIALS	REVISION DETAILS
NABLUS SPECIALIZED COURT			
PROJECT No. :			
ISSUE : DESIGN DEVELOPMENT			
DRAWING : Parking Floor IT Systems			
	DRAWN : DIAMOND STAFF	APPROVED: DIAMOND STAFF	DATE: JUNE, 2021
	CHECKED: DIAMOND STAFF		SCALE: 1/100
SAFFARINI & ASSOCIATES Ramallah Fax 02-2959363 Tel 02-2987675			E301 Rev.: 2

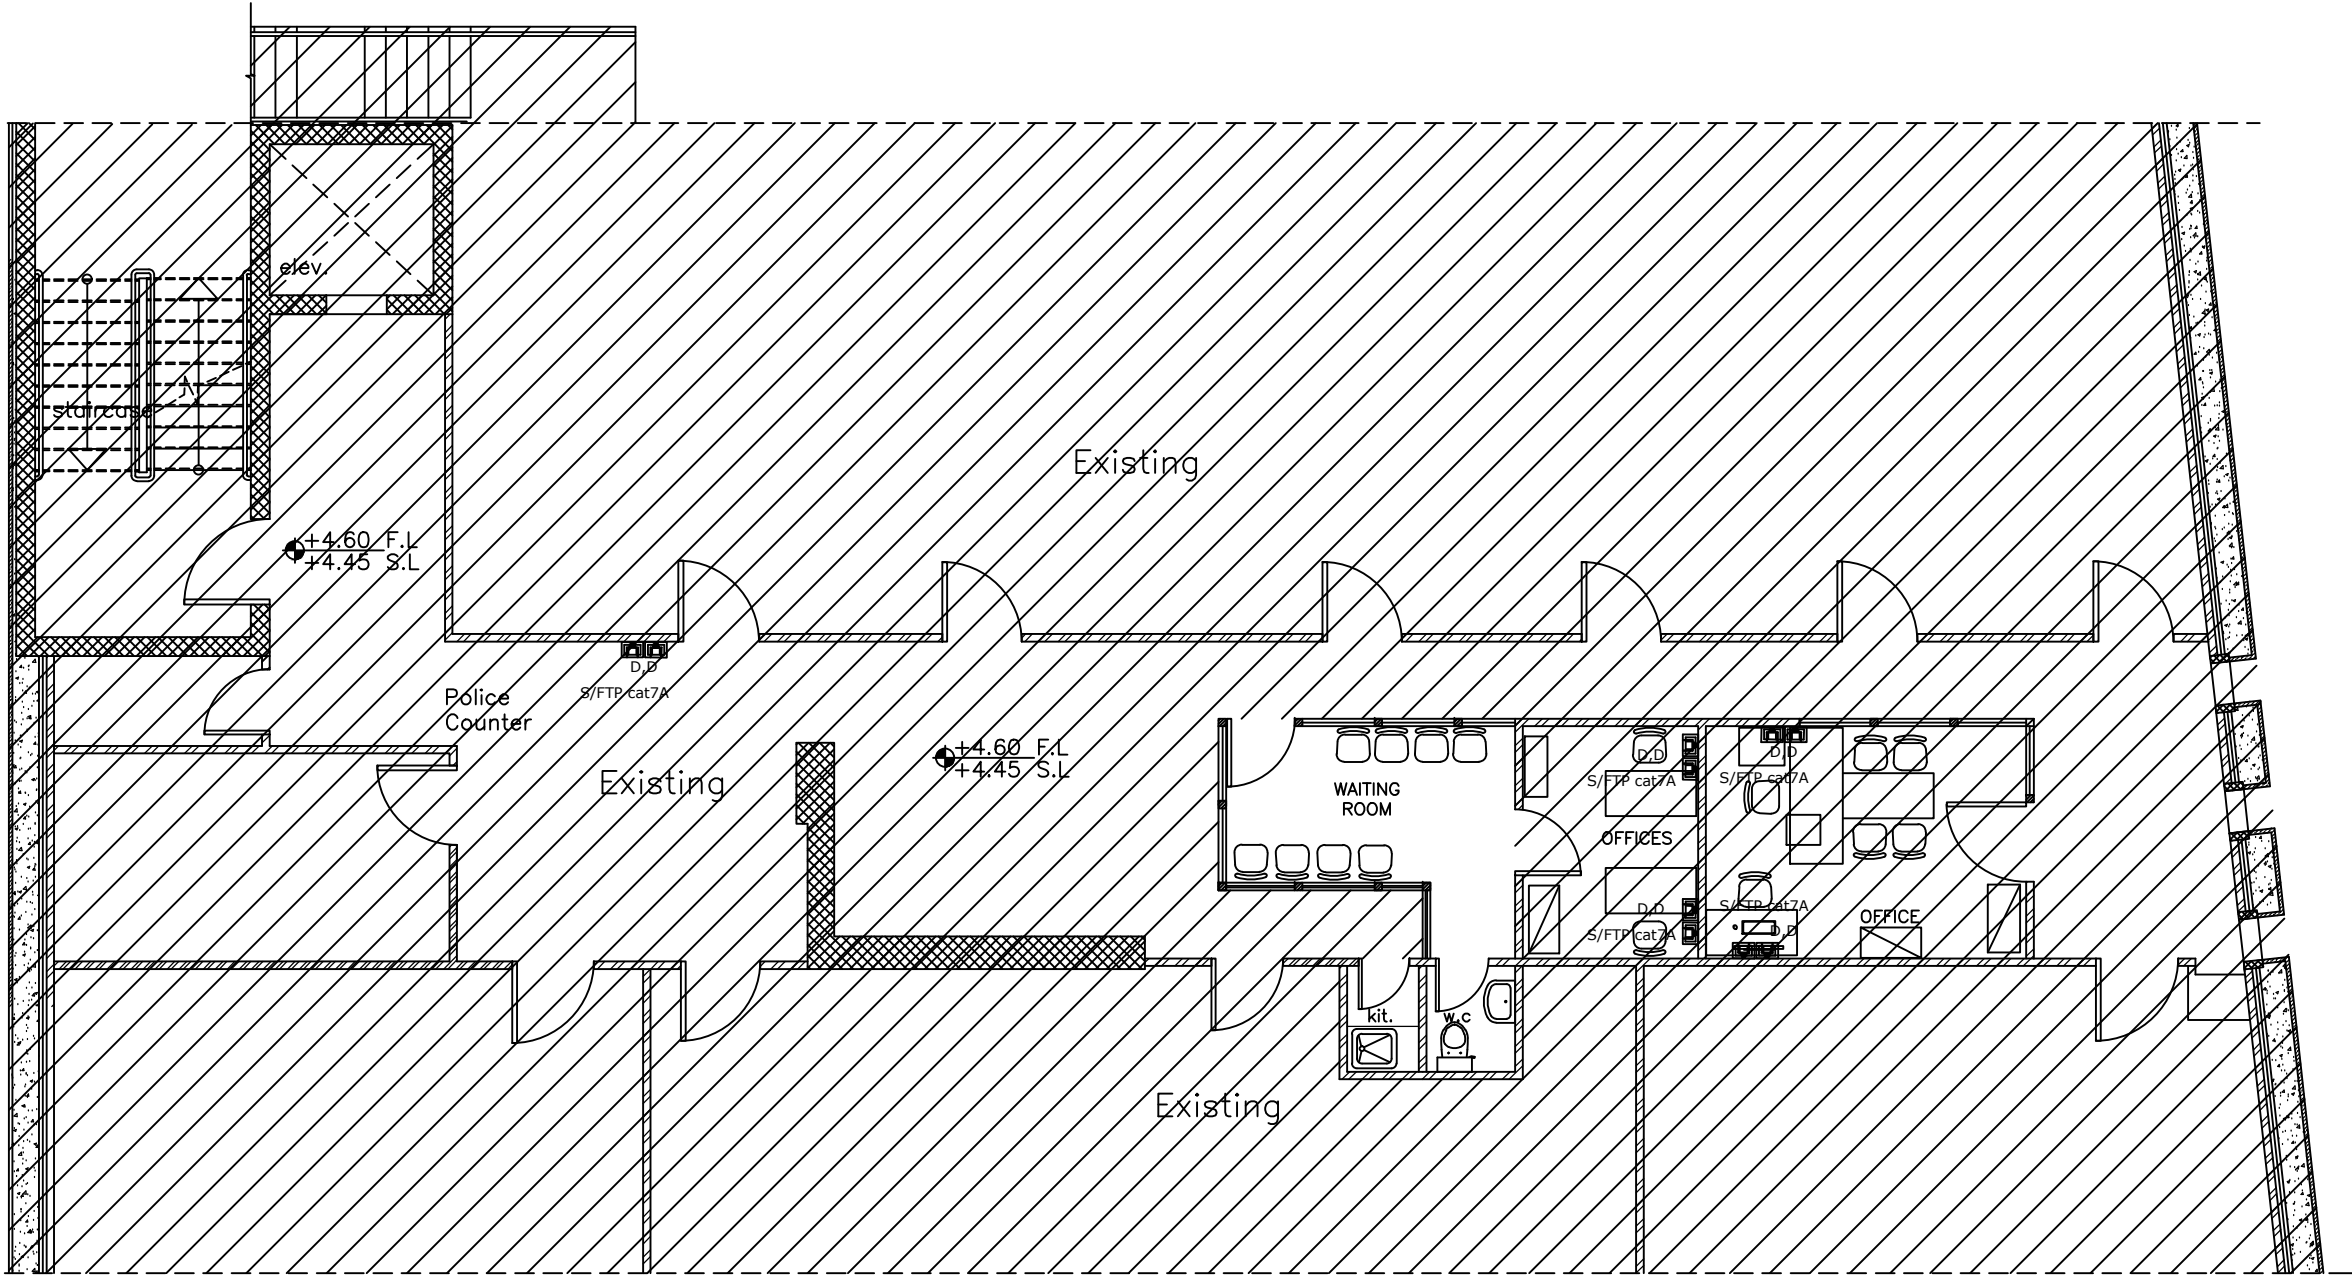

NOTES :

- 1- S/FTP cat7A shall be installed for each Data and voice outlets connected back to existing data cabinet.
- 2- Height for all sockets = 40 cm F.F.L. unless otherwise mentioned.
- 3- D: Data Outlet, V: Voice Outlet

IT & TELECOMMUNICATION SYSTEMS	
	RJ45 CAT 7A TELEPHONE SOCKET
	RJ45 CAT 7 A DATA SOCKET
	DATA CABINET BOX
	30cm CABLE LADDER


REVISION	DATE OF REVISION	INITIALS	REVISION DETAILS
----------	------------------	----------	------------------

NABLUS SPECIALIZED COURT

PROJECT No. :			
ISSUE : DESIGN DEVELOPMENT			
DRAWING : First Floor IT Systems			
	DRAWN : DIAMOND STAFF	APPROVED: DIAMOND STAFF	DATE: JUNE, 2021
	CHECKED: DIAMOND STAFF		SCALE: 1/100

SAFFARINI & ASSOCIATES
Ramallah
Fax 02-2959363
Tel 02-2987675

E302
Rev.: 2

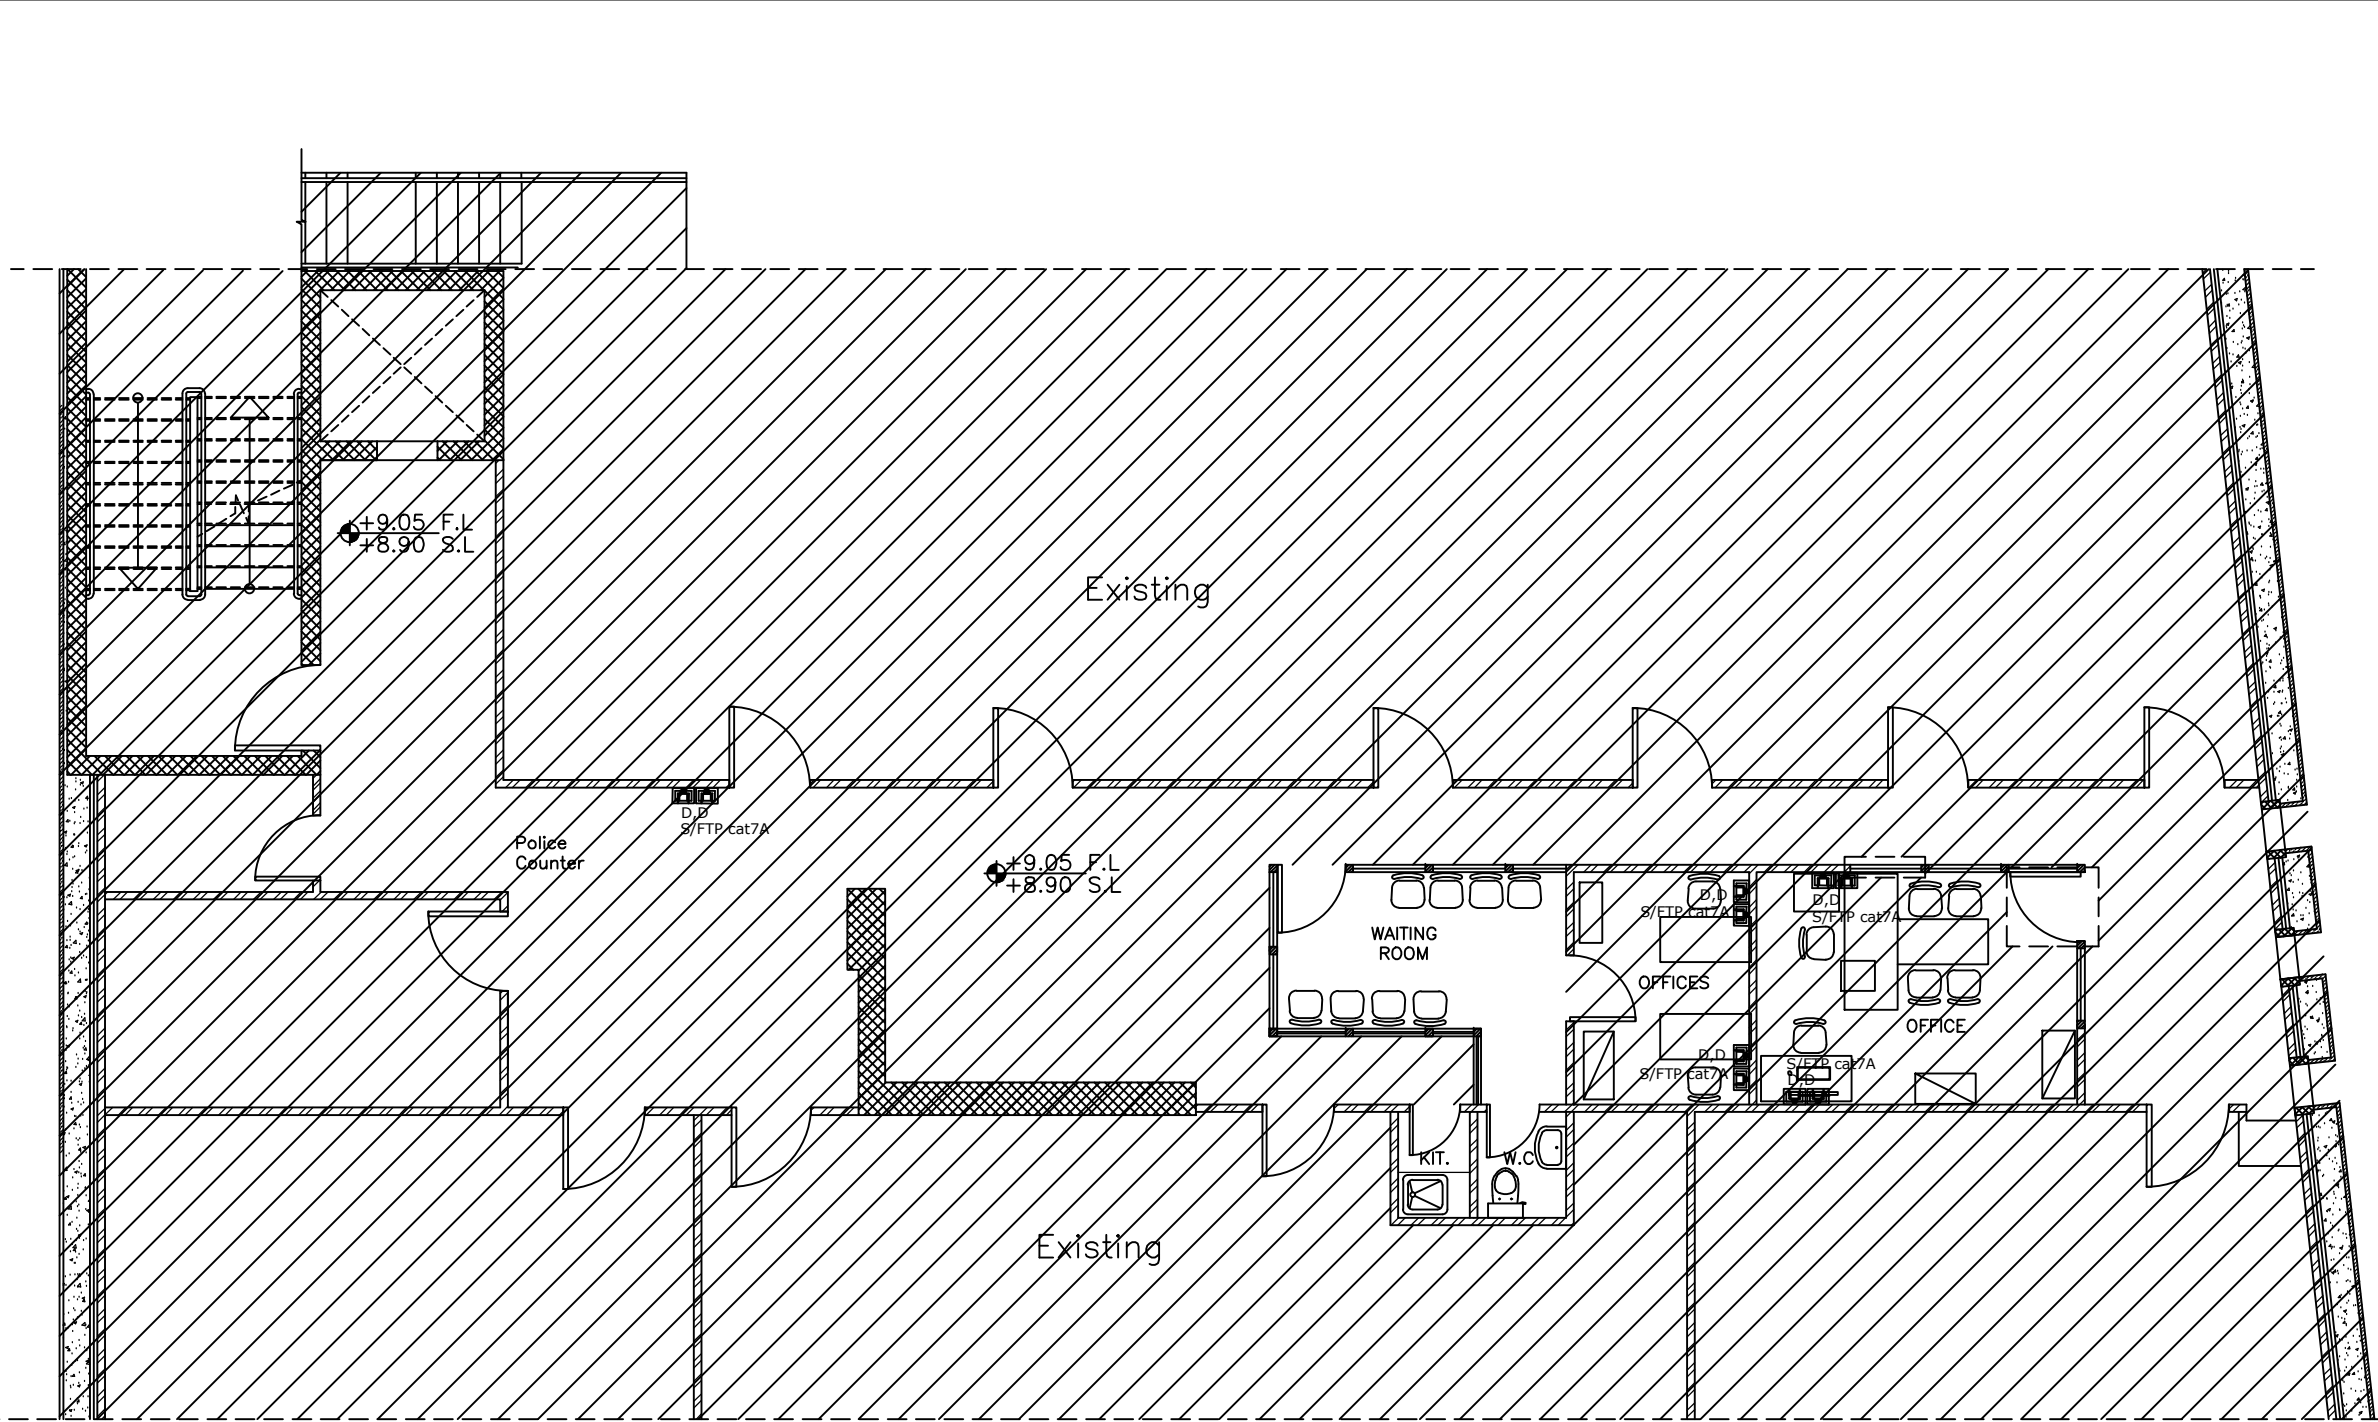

NOTES :

- 1- S/FTP cat7A shall be installed for each Data and voice outlets connected back to existing data cabinet.
- 2- Height for all sockets = 40 cm F.F.L. unless otherwise mentioned.
- 3- D: Data Outlet, V: Voice Outlet

IT & TELECOMMUNICATION SYSTEMS	
▼	RJ45 CAT 7A TELEPHONE SOCKET
■	RJ45 CAT 7 A DATA SOCKET
■	DATA CABINET BOX
■	30cm CABLE LADDER

REVISION	DATE OF REVISION	INITIALS	REVISION DETAILS
----------	------------------	----------	------------------

NABLUS SPECIALIZED COURT

PROJECT No. :

ISSUE : DESIGN DEVELOPMENT


DRAWING : Second floor IT Systems

⊕	DRAWN : DIAMOND STAFF	APPROVED: DIAMOND STAFF	DATE: JUNE, 2021
	CHECKED: DIAMOND STAFF		SCALE: 1/100

SAFFARINI & ASSOCIATES
Ramallah
Fax 02-2959363
Tel 02-2987675

E303

Rev.: 2

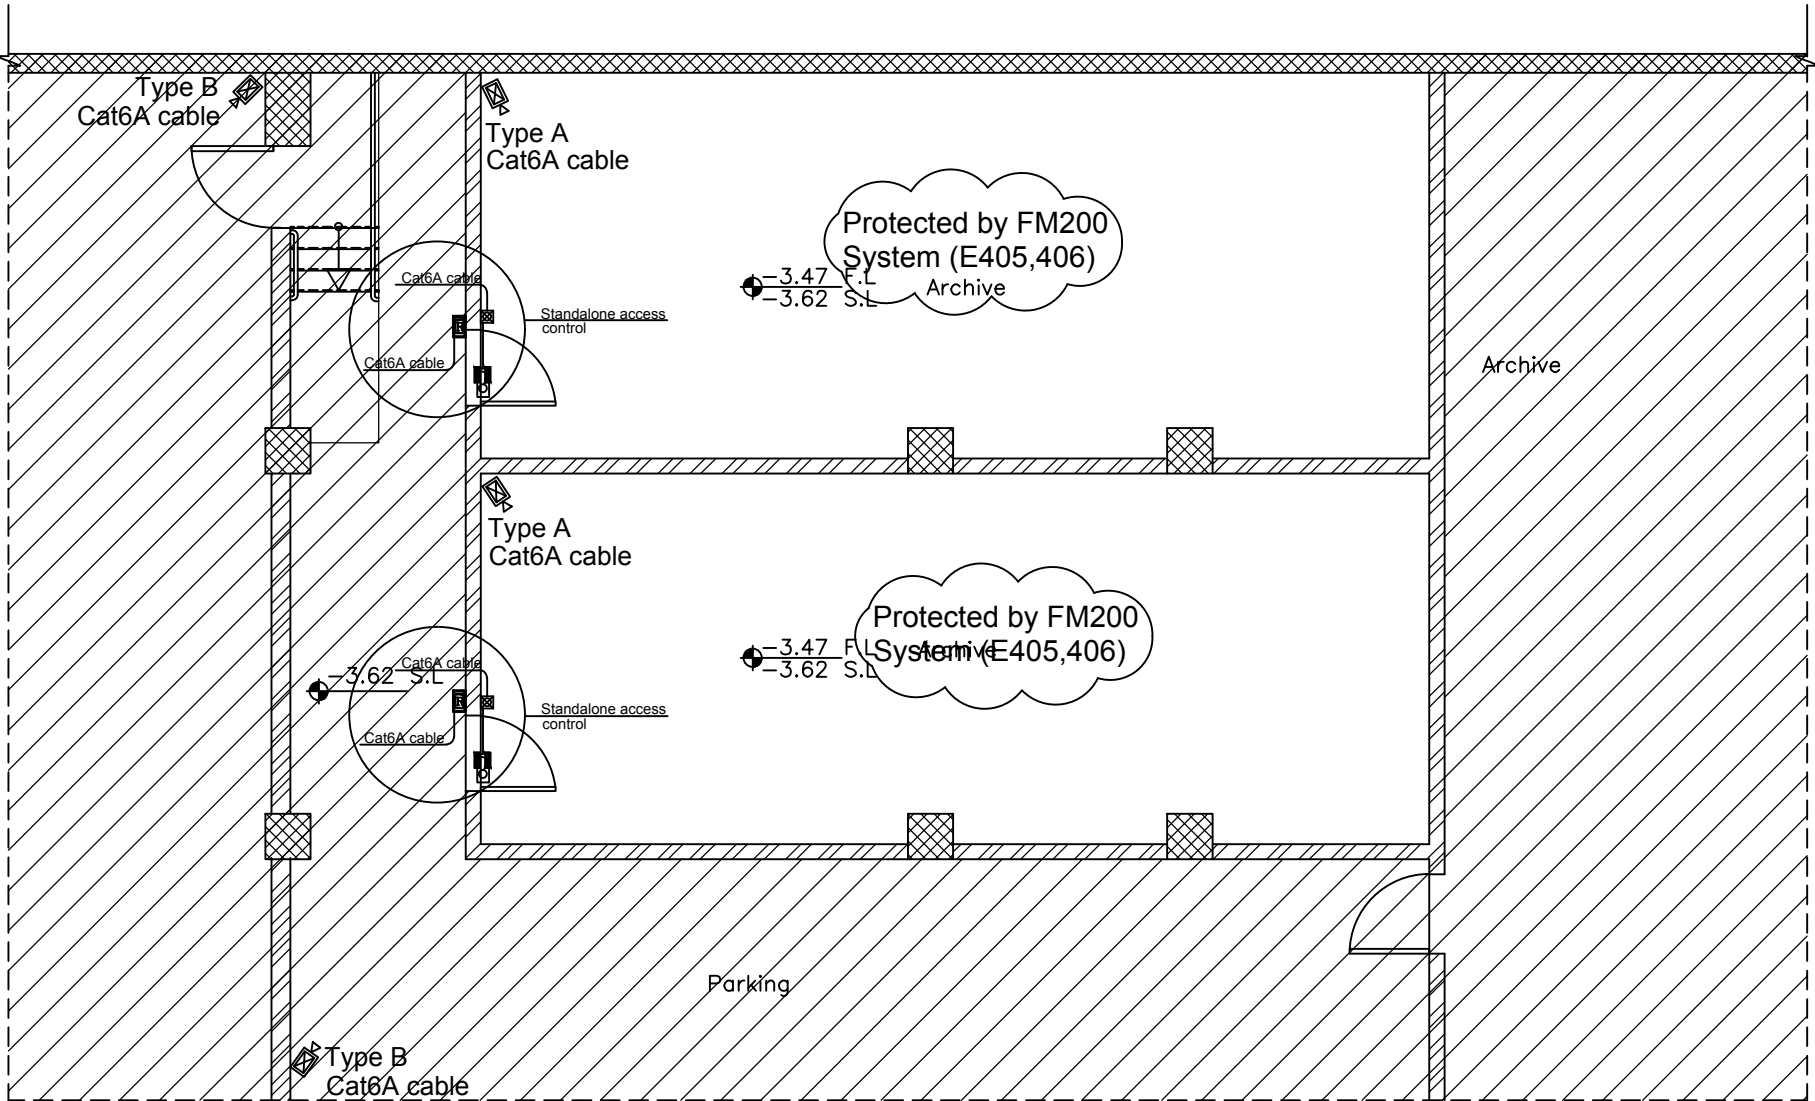

NOTES :

Cameras should have special data points and cat6A cables marked with a unique color different than data points, connected back to existing data cabinet

- CCTV Legend:
- Type A: Full HD, 5Mp, IP color wide dynamic camera, 2.8-10 mm lenses
 - Type B: HD, 1080p, IP color wide dynamic outdoor dome camera, 20m distance view, with arm if required.(IP65)
 - Type C: 5Mp IP color wide dynamic fisheye camera

CCTV & ACCESS CONTROL SYSTEMS	
	42" LCD screen
	READER
	LOCK
	MAGNETIC CONTACT FOR ACCESS DOOR
	PUSH BUTTON
	JUNCTION BOX
	INTERNAL CAMERA
	EXTERNAL CAMERA
	DATA CABINET BOX
	30cm CABLE LADDER

REVISION	DATE OF REVISION	INITIALS	REVISION DETAILS
----------	------------------	----------	------------------


NABLUS SPECIALIZED COURT

PROJECT No. :			
ISSUE : DESIGN DEVELOPMENT			
DRAWING : Parking Floor Low Current Systems			
	DRAWN : DIAMOND STAFF	APPROVED: DIAMOND STAFF	DATE: JUNE, 2021
	CHECKED: DIAMOND STAFF		SCALE: 1/100

SAFFARINI & ASSOCIATES
Ramallah
Fax 02-2959363
Tel 02-2987675

E401

Rev.: 2

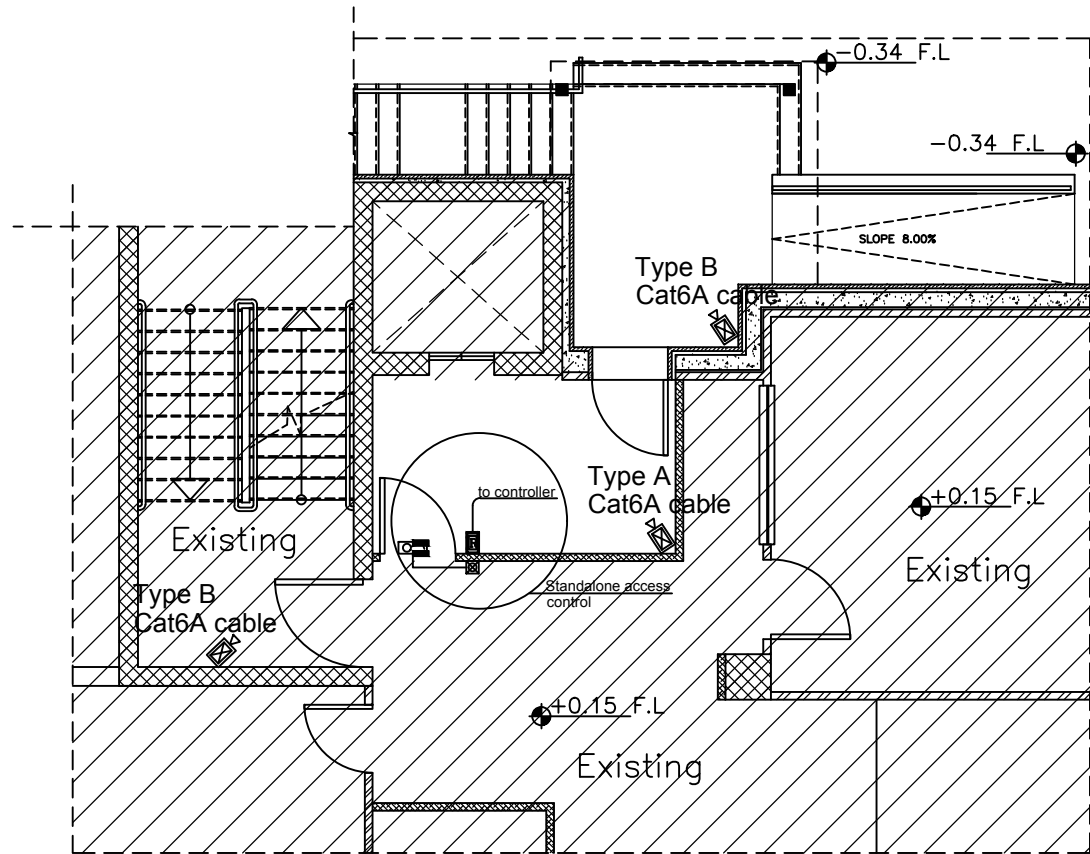

NOTES :

Cameras should have special data points and cat6A cables marked with a unique color different than data points, connected back to existing data cabinet

- CCTV Legend:
- Type A: Full HD, 5Mp, IP color wide dynamic camera, 2.8-10 mm lenses
 - Type B: HD, 1080p, IP color wide dynamic outdoor dome camera, 20m distance view, with arm if required.(IP65)
 - Type C: 5Mp IP color wide dynamic fisheye camera

CCTV & ACCESS CONTROL SYSTEMS	
	42" LCD screen
	READER
	LOCK
	MAGNETIC CONTACT FOR ACCESS DOOR
	PUSH BUTTON
	JUNCTION BOX
	INTERNAL CAMERA
	EXTERNAL CAMERA
	DATA CABINET BOX
	30cm CABLE LADDER


REVISION	DATE OF REVISION	INITIALS	REVISION DETAILS
----------	------------------	----------	------------------

NABLUS SPECIALIZED COURT

PROJECT No. :			
ISSUE : DESIGN DEVELOPMENT			
DRAWING : Ground Floor Low Current Systems			
	DRAWN : DIAMOND STAFF	APPROVED: DIAMOND STAFF	DATE: JUNE, 2021
	CHECKED: DIAMOND STAFF		SCALE: 1/100

SAFFARINI & ASSOCIATES
Ramallah
Fax 02-2959363
Tel 02-2987675

E402
Rev.: 2

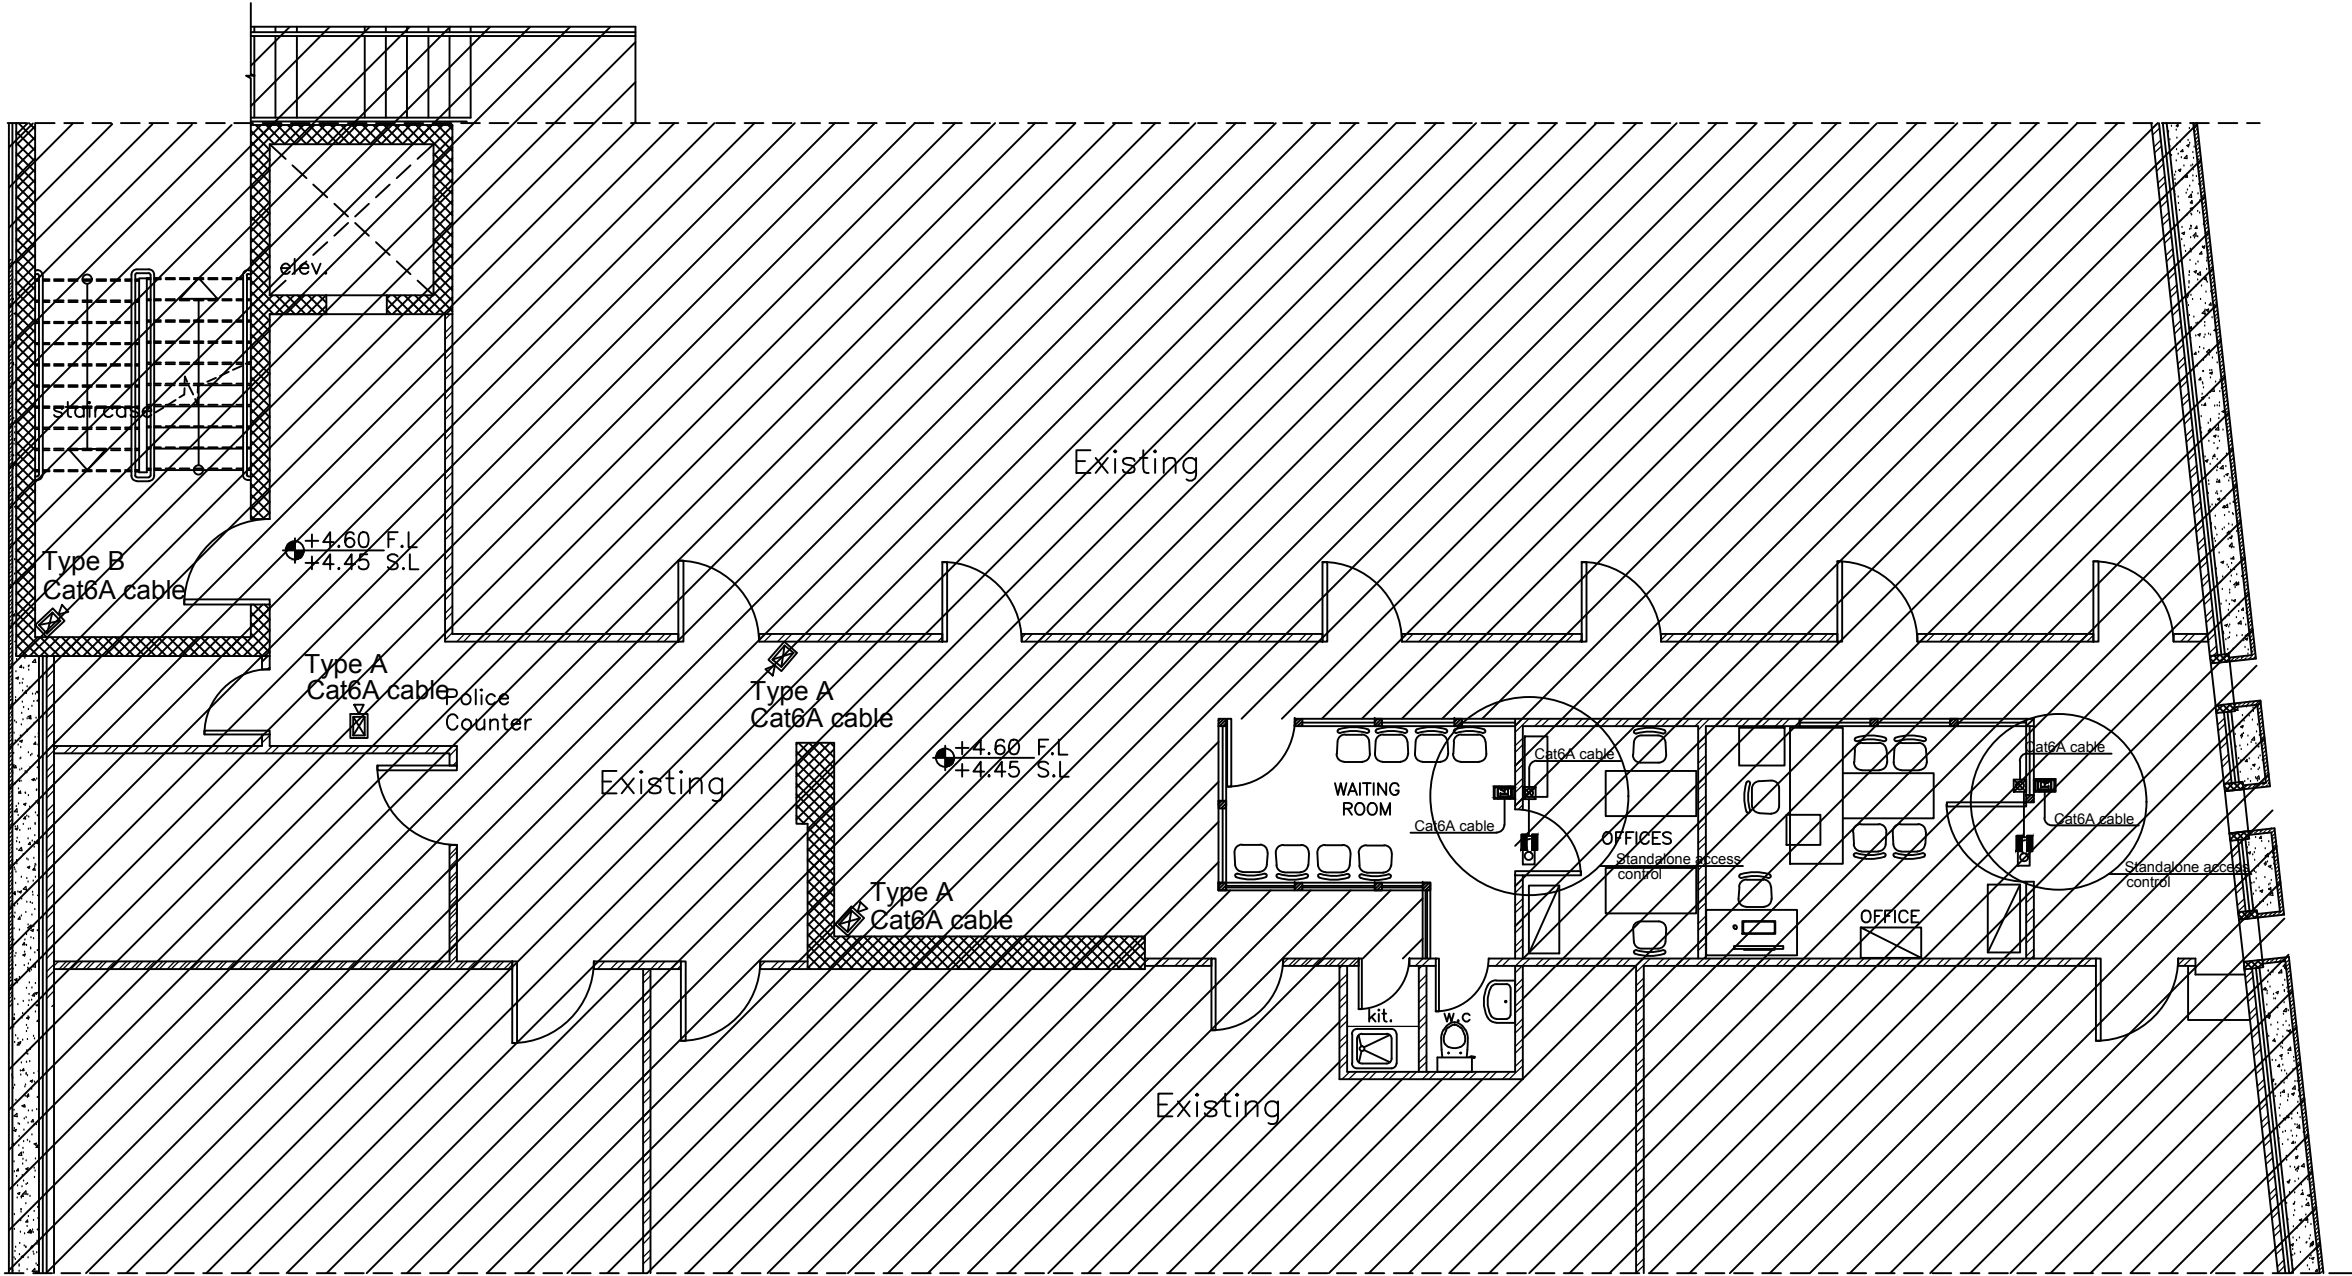


NOTES :

Cameras should have special data points and cat6A cables marked with a unique color different than data points, connected back to existing data cabinet

- CCTV Legend:
- Type A: Full HD, 5Mp, IP color wide dynamic camera, 2.8-10 mm lenses
 - Type B: HD, 1080p, IP color wide dynamic outdoor dome camera, 20m distance view, with arm if required.(IP65)
 - Type C: 5Mp IP color wide dynamic fisheye camera

CCTV & ACCESS CONTROL SYSTEMS	
	42" LCD screen
	READER
	LOCK
	MAGNETIC CONTACT FOR ACCESS DOOR
	PUSH BUTTON
	JUNCTION BOX
	INTERNAL CAMERA
	EXTERNAL CAMERA
	DATA CABINET BOX
	30cm CABLE LADDER

REVISION	DATE OF REVISION	INITIALS	REVISION DETAILS
NABLUS SPECIALIZED COURT			
PROJECT No. :			
ISSUE : DESIGN DEVELOPMENT			
DRAWING : First Floor Low Current Systems			
	DRAWN : DIAMOND STAFF	APPROVED: DIAMOND STAFF	DATE: JUNE, 2021
	CHECKED: DIAMOND STAFF		SCALE: 1/100
SAFFARINI & ASSOCIATES Ramallah Fax 02-2959363 Tel 02-2987675			E403 Rev.: 2

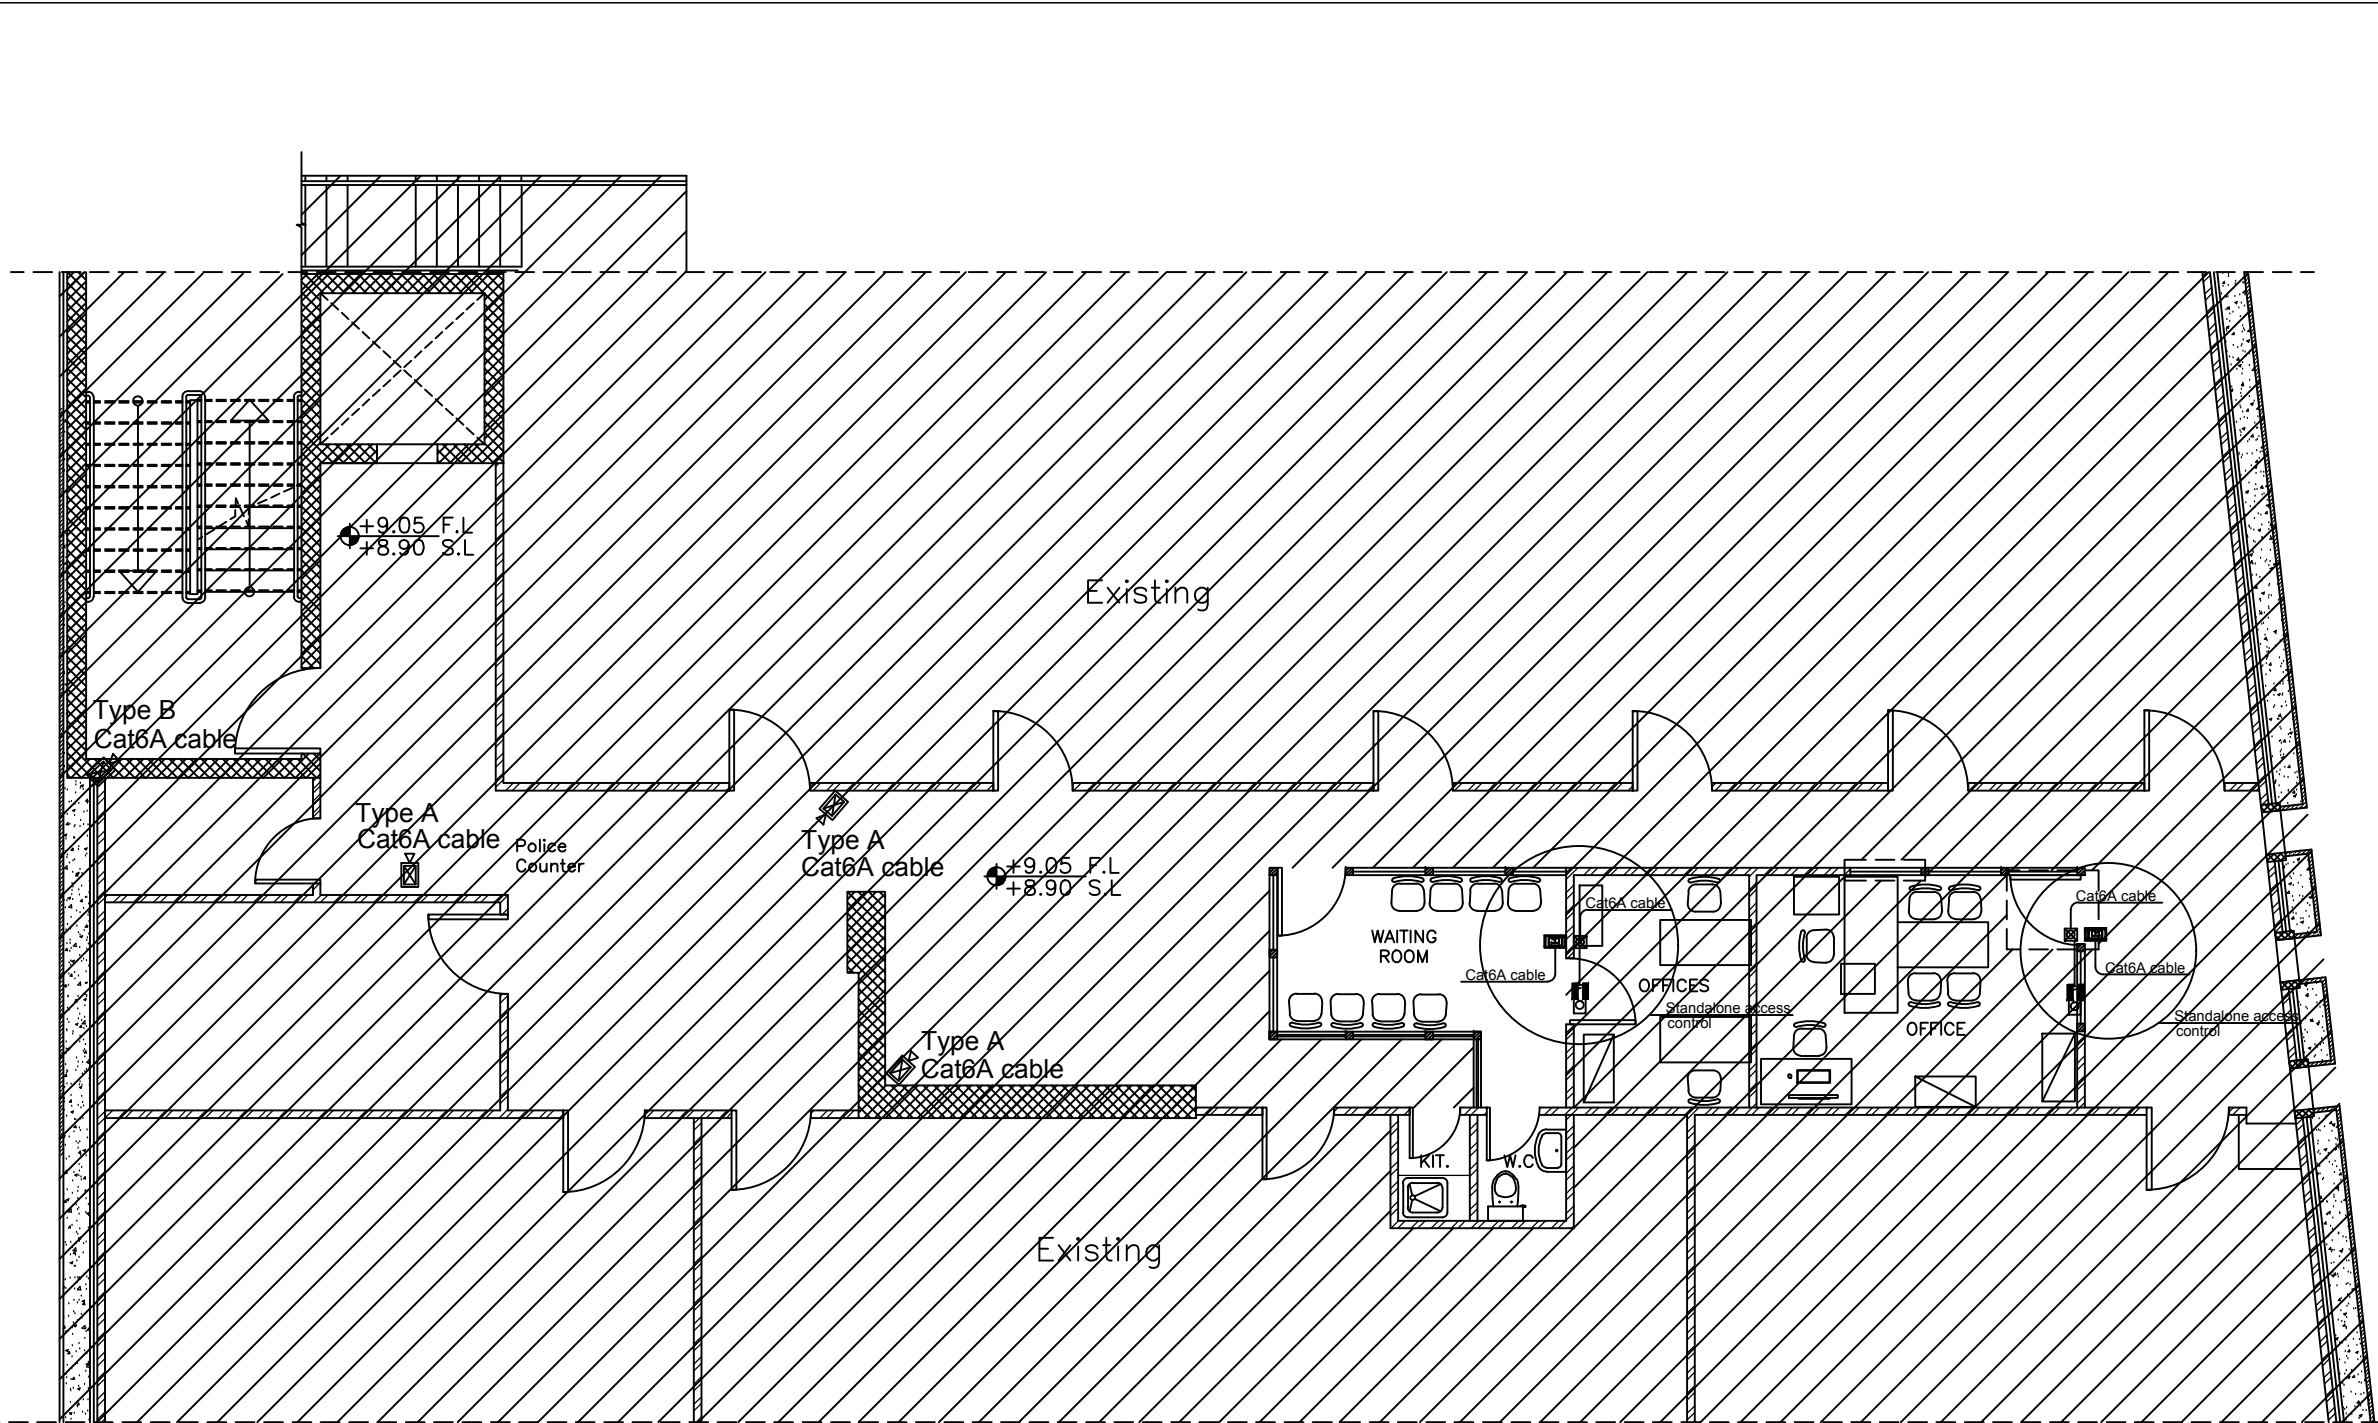



NOTES :

Cameras should have special data points and cat6A cables marked with a unique color different than data points, connected back to existing data cabinet

- CCTV Legend:
- Type A: Full HD, 5Mp, IP color wide dynamic camera, 2.8-10 mm lenses
 - Type B: HD, 1080p, IP color wide dynamic outdoor dome camera, 20m distance view, with arm if required.(IP65)
 - Type C: 5Mp IP color wide dynamic fisheye camera

CCTV & ACCESS CONTROL SYSTEMS	
	42" LCD screen
	READER
	LOCK
	MAGNETIC CONTACT FOR ACCESS DOOR
	PUSH BUTTON
	JUNCTION BOX
	INTERNAL CAMERA
	EXTERNAL CAMERA
	DATA CABINET BOX
	30cm CABLE LADDER

REVISION	DATE OF REVISION	INITIALS	REVISION DETAILS
NABLUS SPECIALIZED COURT			
PROJECT No. :			
ISSUE : DESIGN DEVELOPMENT			
DRAWING : Second Floor Low Current Systems			
	DRAWN : DIAMOND STAFF	APPROVED: DIAMOND STAFF	DATE: JUNE, 2021
	CHECKED: DIAMOND STAFF		SCALE: 1/100
SAFFARINI & ASSOCIATES Ramallah Fax 02-2959363 Tel 02-2987675			E404 Rev.: 2

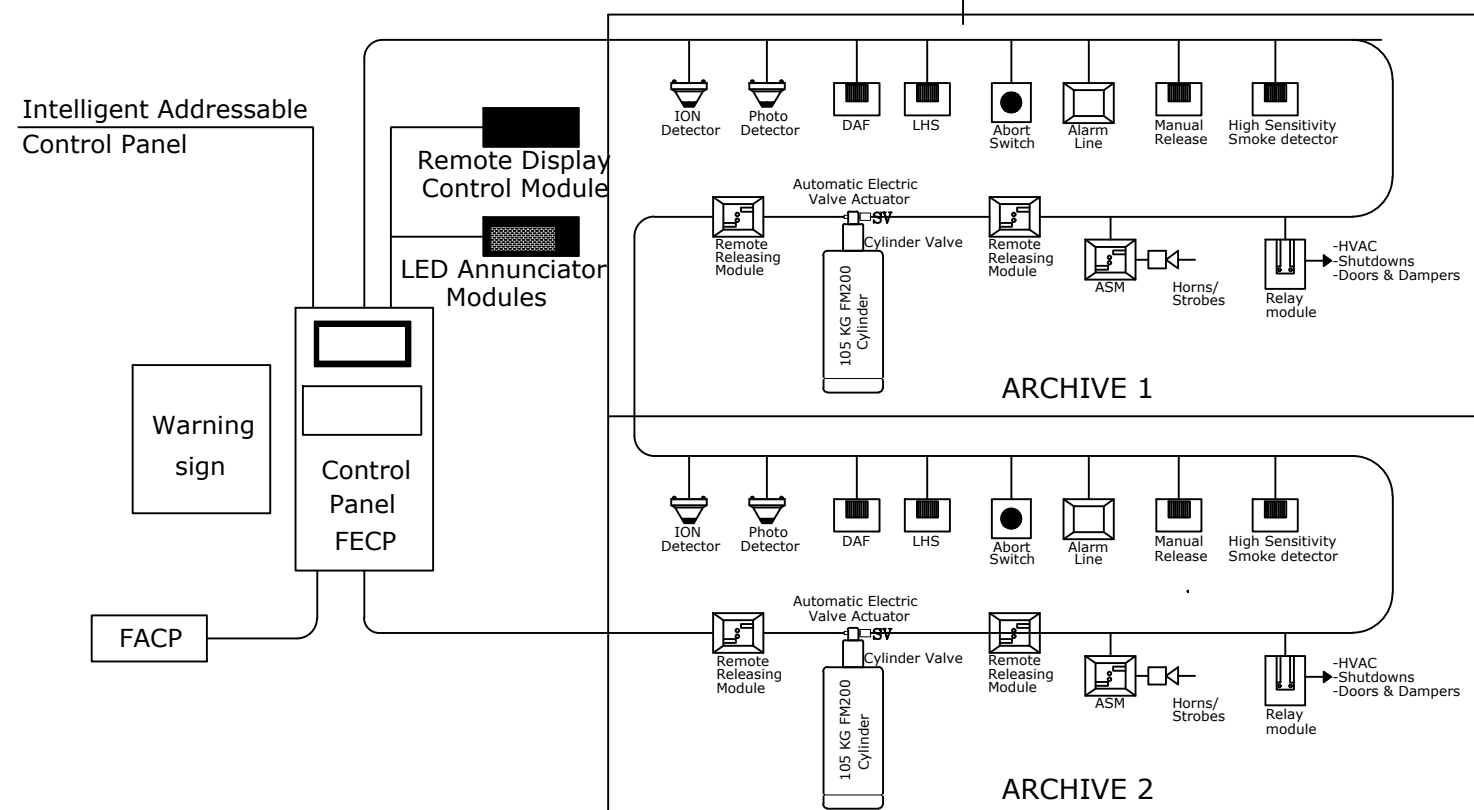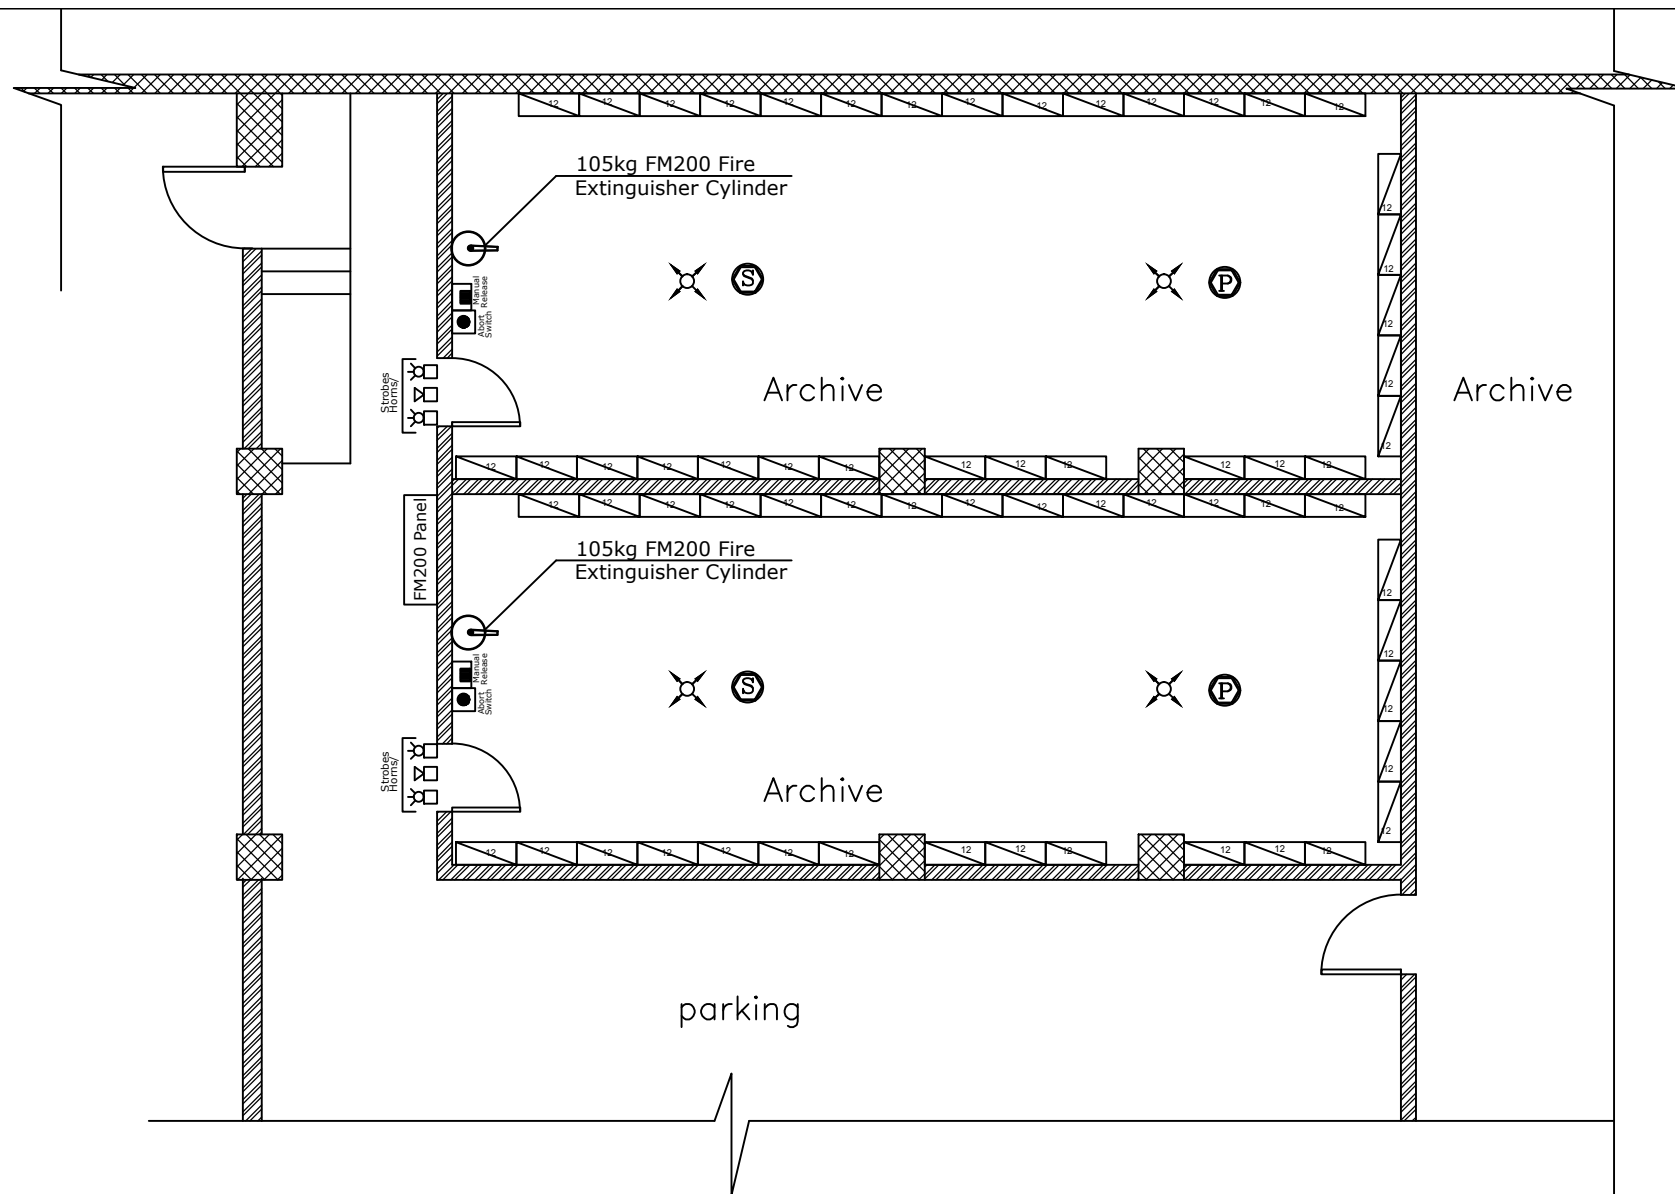

NOTES :

REVISION	DATE OF REVISION	INITIALS	REVISION DETAILS
----------	------------------	----------	------------------

NABLUS SPECIALIZED COURT

PROJECT No. :

ISSUE : DESIGN DEVELOPMENT

DRAWING : FM200 System Details

	DRAWN : DIAMOND STAFF	APPROVED: DIAMOND STAFF	DATE: JUNE, 2021
	CHECKED: DIAMOND STAFF		SCALE: 1/100

SAFFARINI & ASSOCIATES
Ramallah
Fax 02-2959363
Tel 02-2987675

E405

Rev.: 2

SEQUENCE OF OPERATION

1. The system shall be total flooding FM-200 extinguishing system designed to provide a uniform concentration of 7%, at normal average ambient temperature, minimum of

The amount of FM-200 to be provided shall be the amount required to obtain and hold the minimum uniform concentration for 10 minutes.

2. Cross-Zoned detection include devices located in 2 separate zones. Sound alarm on activating single-detection device (1st alarm level for High Sensitivity Smoke Detection (HSSD) systems), and discharge extinguishing agent on actuating single-detection device in other zone (2nd alarm level for HSSD systems)
3. The system shall be actuated by a combination of ionization and photoelectric smoke detectors. Automatic operation in each separate protected area shall be as follows:
 - a) Actuation of one detector in either loop shall:
 1. Illuminate the respective zone (circuit) lamp on the control unit.
 2. Energize a pre-alarm audible or audible/visual signal associated with that area in which the detector was operated.
 3. Actuate door closer/holders on access doors to the protected area.
 4. Transmit a signal to the building's fire alarm system.
 - b) Actuation of a second detector in the same area, but on the second detection loop shall:
 1. Illuminate the respective zone (circuit) lamp on the control unit.
 2. Energize an evacuation audible or audible/visual signal associated with that area in which the detector was operated.
 3. Start time-delay sequence.
 4. Shut down ventilation system and/or close dampers.
 - c) Discharge of the FM-200 shall occur at the end of time-delay period.
4. The system shall be capable of being actuated by manual discharge stations located at each fire exit. Operation of manual discharge station shall duplicate the cross-zones sequence description above, except that time-delay shall be bypassed.

Note: Valve solenoid should be supervised by a dedicated module.

LEGEND

	FM 200 GAS NOZZLE
	FM 200 GAS CYLINDER
	ACTUATOR
	PRESSURE SWITCH
	PIPE
	FIRE EXTINGUISHING CONTROL PANEL
	FIRST STAGE ALARM BELL
	SECOND STAGE SIREN
	COMBINED HORN & BEACON LIGHT
	OPTICAL DETECTOR
	SMOKE DETECTOR
	PRESSURE SWITCH
	SOLOINOID VALVE
	END OF LINE RESISTOR
	ABORT SWITCH

FM200 Riser Diagram & NOTES


1. THE DESIGN, INSTALLATION, AND TESTING OF CLEAN AGENT SYSTEMS SHALL BE IN ACCORDANCE WITH REGULATIONS AND NFPA 2001
2. CLEAN AGNET STORAGE SHALL NOT BE STORED WITHIN THE PROTECTED ENCLOSURE THEY SHALL BE EASILY ACCESSIBLE FROM MAIN ENTERANCE
3. THE CONTROL PANNEL SHALL BE LOCATED EXTERNAL TO PROTECTED ENCLOSURE
4. AT LEAST ONE MANUAL RELEASE PUSH BUTTON SHALL BE PROVIDED EXTERNAL TO PROTECTED ENCLOSURE AND LOCATED WITHIN 1.5m OF MAIN ENTRANCE
5. AN ABORT SWITCH SHALL BE RPROVIDED WITHIN THE PROTECTED ENCLOSURE
6. THE PROPOSED FM-200 SYSTEM SHALL BE REVISED AND VERIFIED BY SPECIALIST FOR EACH APPLICATIONS
7. FM-200 GAS AND ALL RELATED EQUIPMENT SHALL BE UL LISTED SIZE SHALL BE SELECTED BY MANUFACTURERS TO SUIT THE GAS SIZE .
8. DETAILED HYDRAULIC CALCULATION SHALL BE PROVIDED FOR THE SYSTEM COMPLETE WITH WORK SHOP DRAWINGS SHOWING LOCATION OF ALL TOOLS REQUIRED TO ACTIVATE THE SYSTEM IN PROPER WAY
9. ANY CHANGES IN THE SIZE OF EQUIPMENT AND QUANTITY REQUIRED BASED ON THE SPECIALIST CALCULATIONS SHALL BE CARRIED OUT BY CONTRACTORS WITH OUT ADDITIONAL COSTS .
10. ALL DETECTORS THAT ARE INSTALLED ABOVE FALSE CEILING FLOOR SHALL HAVE AN INDICATION LED SHOWING THEIR STATUS

Cross Alarm Operation								
Inputs	Output Results							
Cross Zone 1		X		X		X		X
Cross Zone 2			X	X			X	X
Pull Station					X	X	X	X
	Normal	Pre-Alert	Pre-Alert	Release and General Alarm	Release and General Alarm	Release and General Alarm	Release and General Alarm	Release and General Alarm

**MFCP BACK-UP POWER SUPPLY (BATTERY) FOR FACP
THE GENERAL REQUIRED FOR BATTERY BACKUP IS THAT THE
SYSTEM ABLE TO WORK FOR 24 HR THEN RUN IN ALARM FOR 30 MIN
PANNEL SPECIFICATION VOLTAGE = 24 VOLTS
BATTERIES 2 X 12 V. & 0.64 AH
STANDBY FOR 24 HOUR**

NOTES

REVISION	DATE OF REVISION	INITIALS	REVISION DETAILS
NABLUS SPECIALIZED COURT			
PROJECT No. :			
ISSUE : DESIGN DEVELOPMENT			
DRAWING : FM200 Riser & Notes			
	DRAWN : DIAMOND STAFF	APPROVED: DIAMOND STAFF	DATE: JUNE, 2021
	CHECKED: DIAMOND STAFF		SCALE: 1/100
SAFFARINI & ASSOCIATES Ramallah Fax 02-2959363 Tel 02-2987675			E406
			Rev.: 2

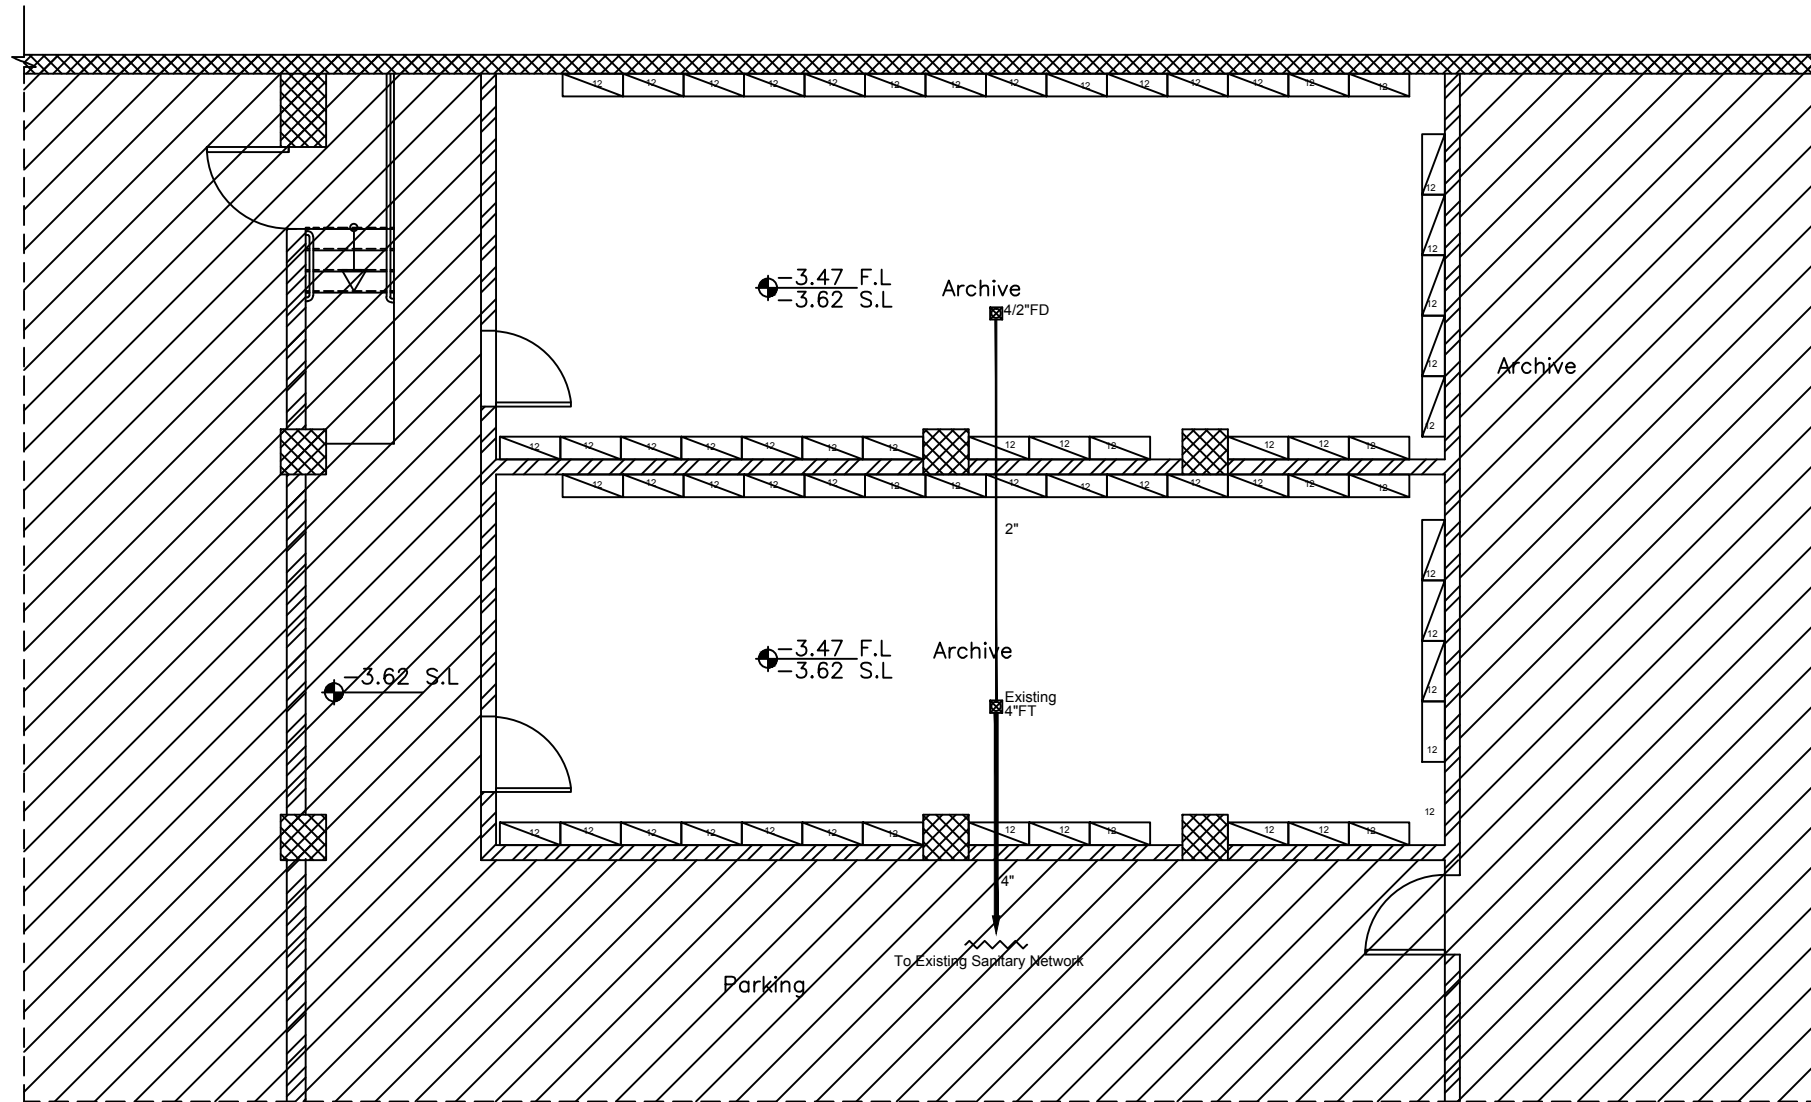

NOTES :

REVISION	DATE OF REVISION	INITIALS	REVISION DETAILS



ESTABLISH A SPECIALIZED COURT
IN NABLUS

PROJECT No. :


ISSUE : TENDER

DRAWING : **Parking Floor
Sanitary System Layout**

	DRAWN : DIAMOND STAFF	APPROVED: DIAMOND STAFF	DATE: JUNE, 2021
	NO :	NO. :	
	CHECKED: DIAMOND STAFF	REF:	SCALE: 1/100
	NO :		

SAFFARINI & ASSOCIATES
Ramallah
Fax 02-2959363
Tel 02-2987675

M101
Rev.: 2

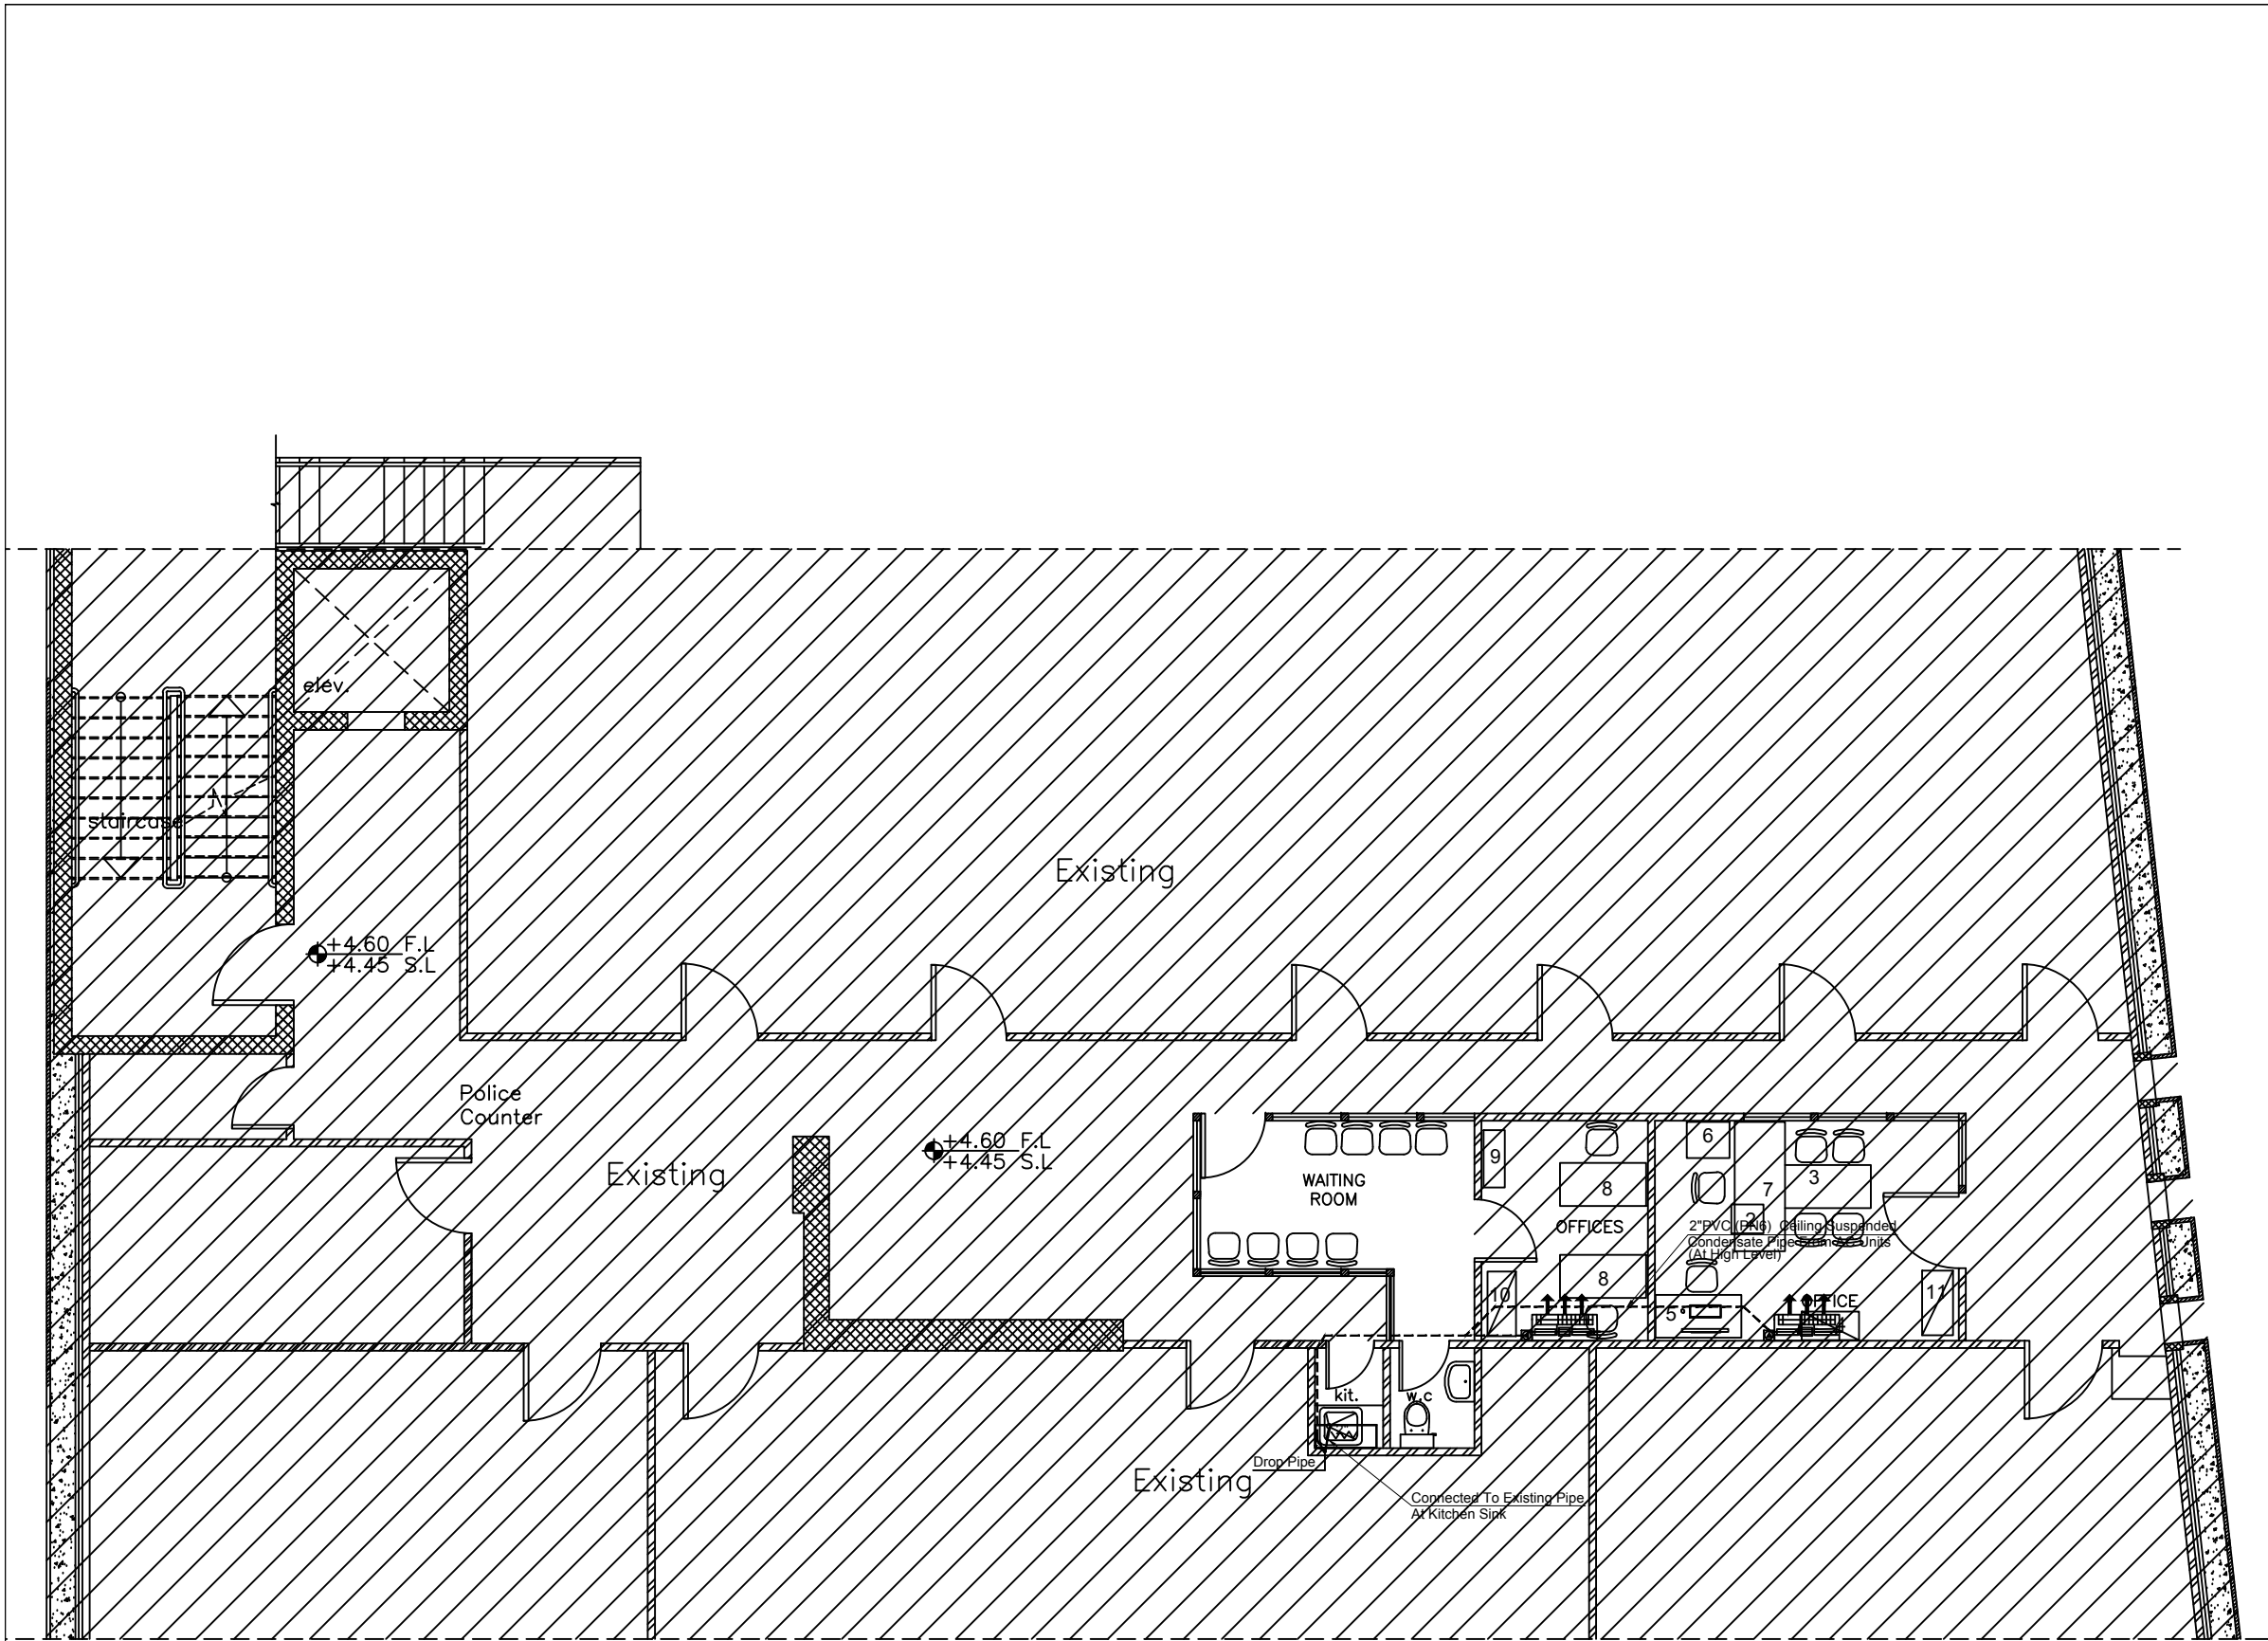

NOTES :

REVISION	DATE OF REVISION	INITIALS	REVISION DETAILS



ESTABLISH A SPECIALIZED COURT
IN NABLUS

PROJECT No. :

ISSUE : TENDER


DRAWING : **First Floor
Sanitary System Layout**

	DRAWN : DIAMOND STAFF	APPROVED: DIAMOND STAFF	DATE: JUNE, 2021
	NO :	NO. :	
	CHECKED: DIAMOND STAFF	REF:	SCALE: 1/100
NO :			

SAFFARINI & ASSOCIATES
Ramallah
Fax 02-2959363
Tel 02-2987675

M102

Rev.: 2

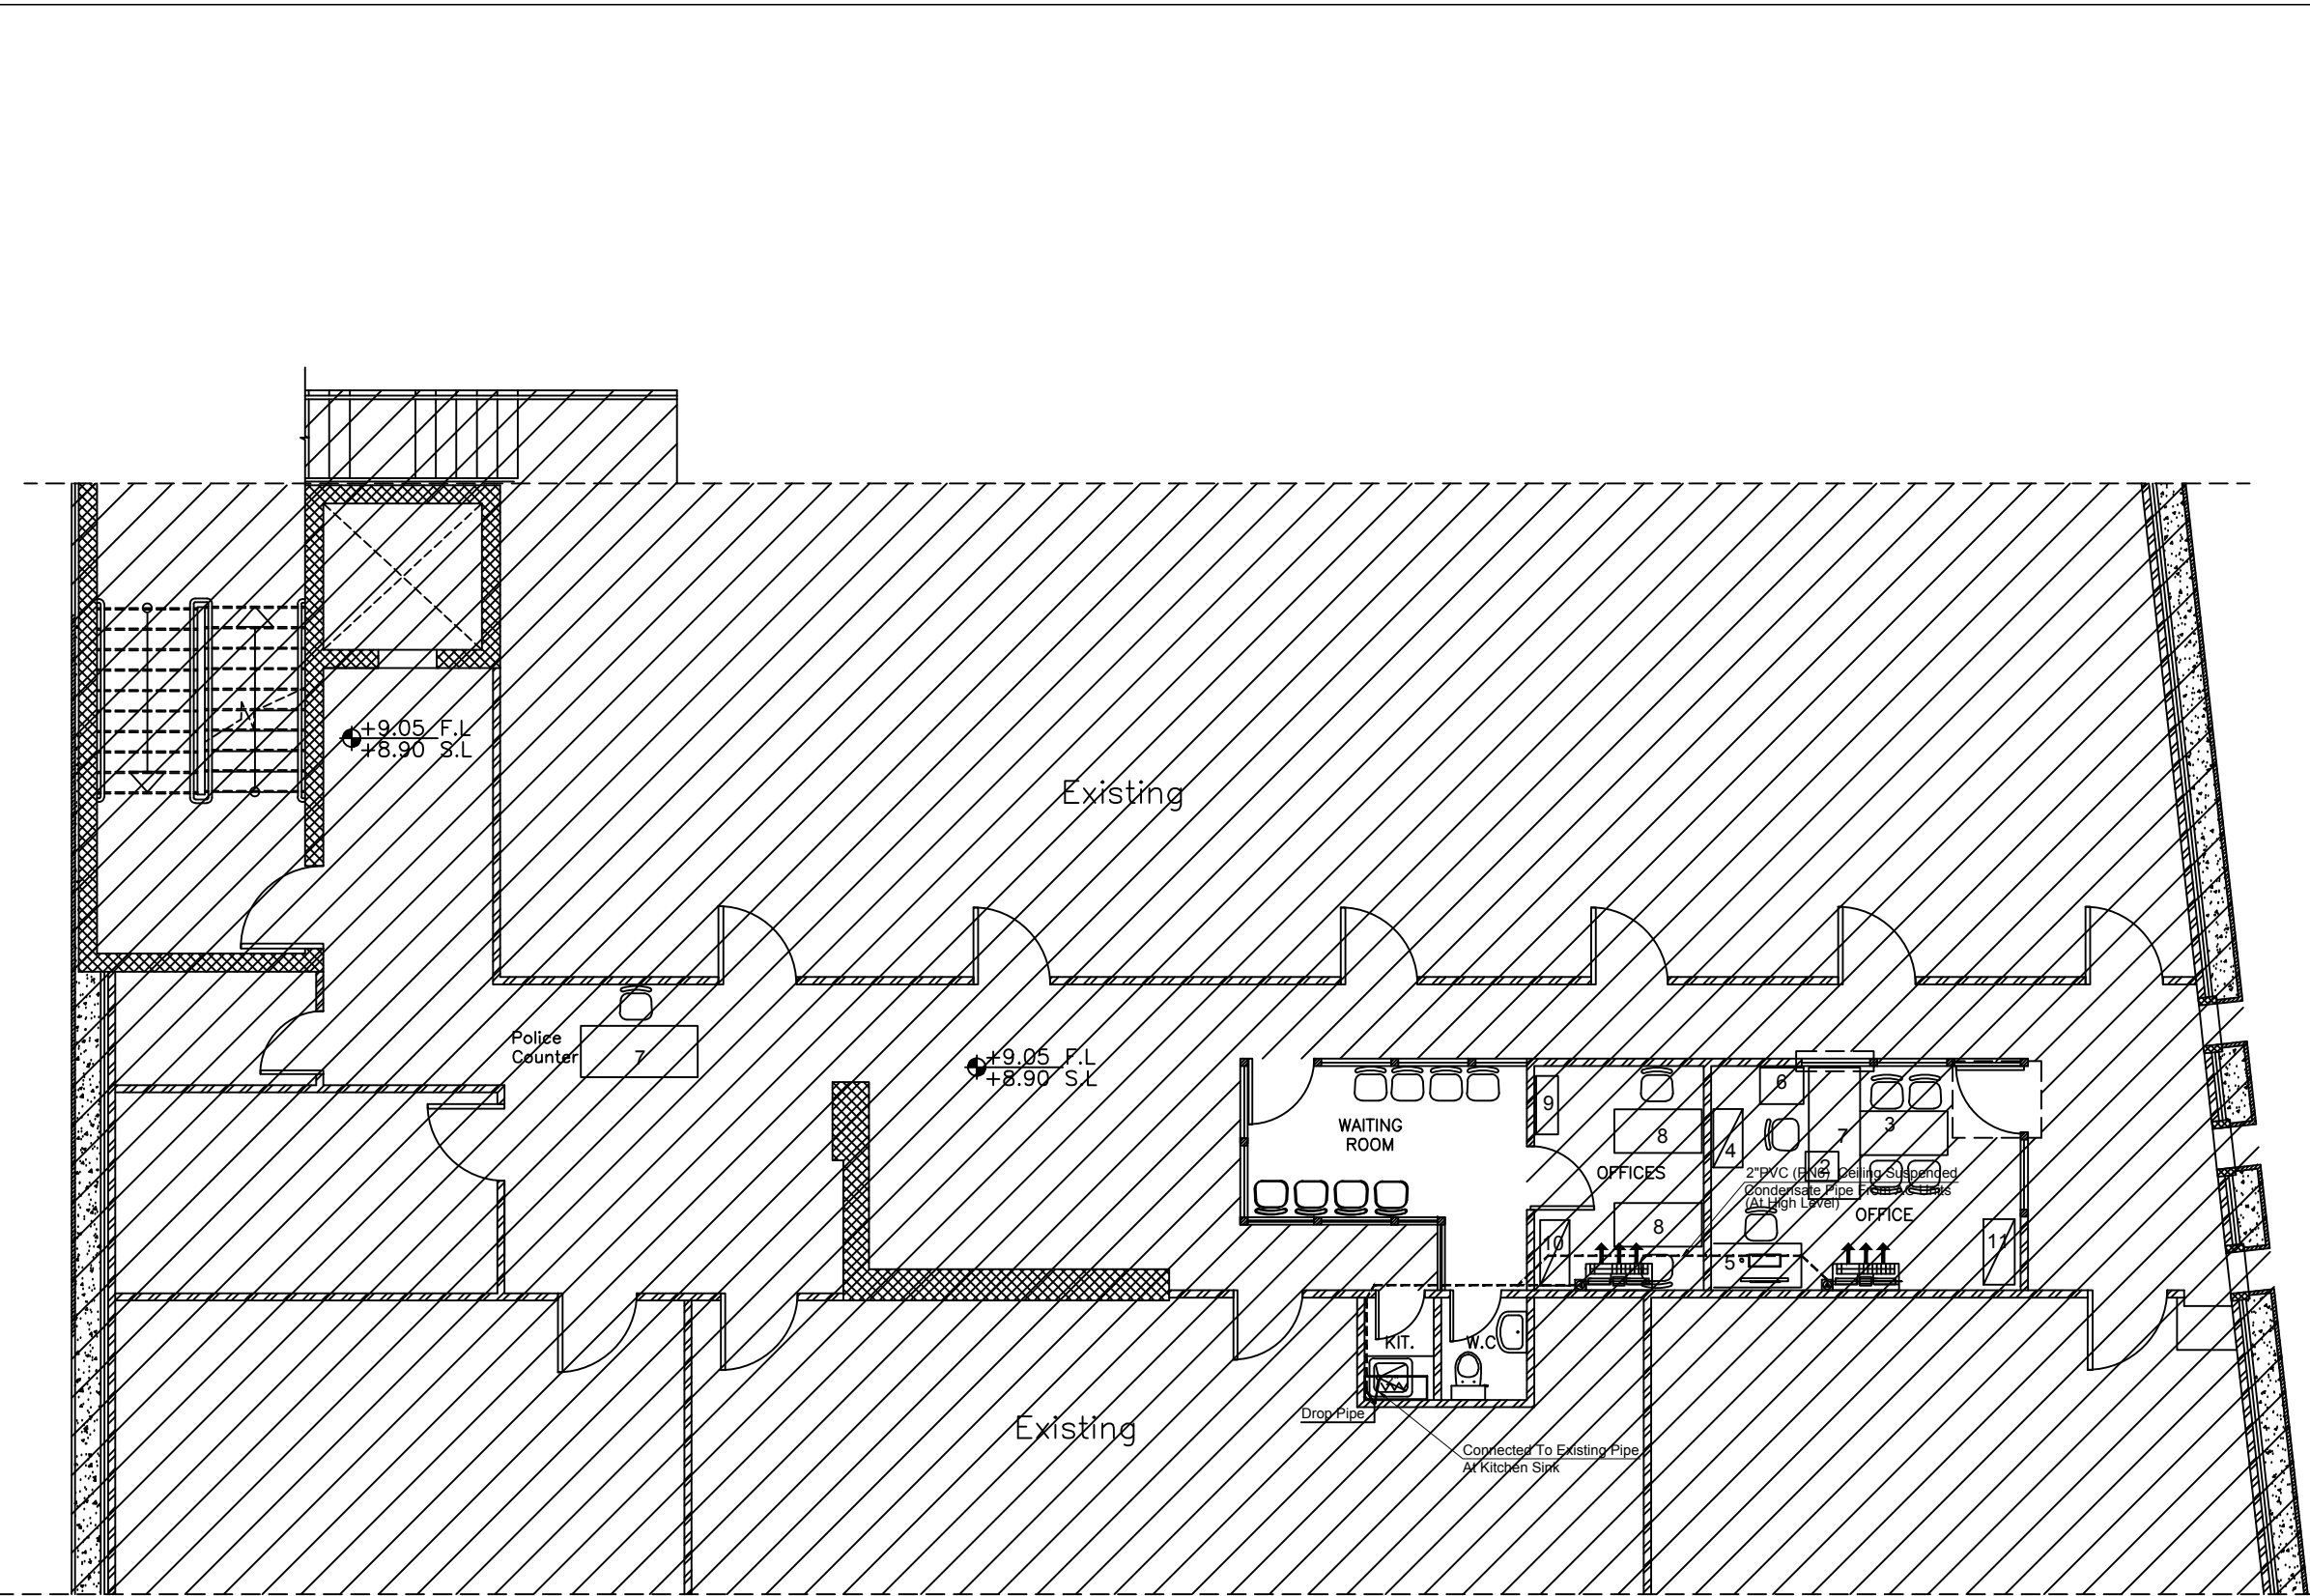

NOTES :

REVISION	DATE OF REVISION	INITIALS	REVISION DETAILS



ESTABLISH A SPECIALIZED COURT
IN NABLUS

PROJECT No. :

ISSUE : TENDER


DRAWING : **Second Floor
Sanitary System Layout**

	DRAWN : DIAMOND STAFF	APPROVED: DIAMOND STAFF	DATE: JUNE, 2021
	NO :	NO. :	
	CHECKED: DIAMOND STAFF	REF:	SCALE: 1/100
	NO :		

SAFFARINI & ASSOCIATES
Ramallah
Fax 02-2959363
Tel 02-2987675

M103

Rev.: 2

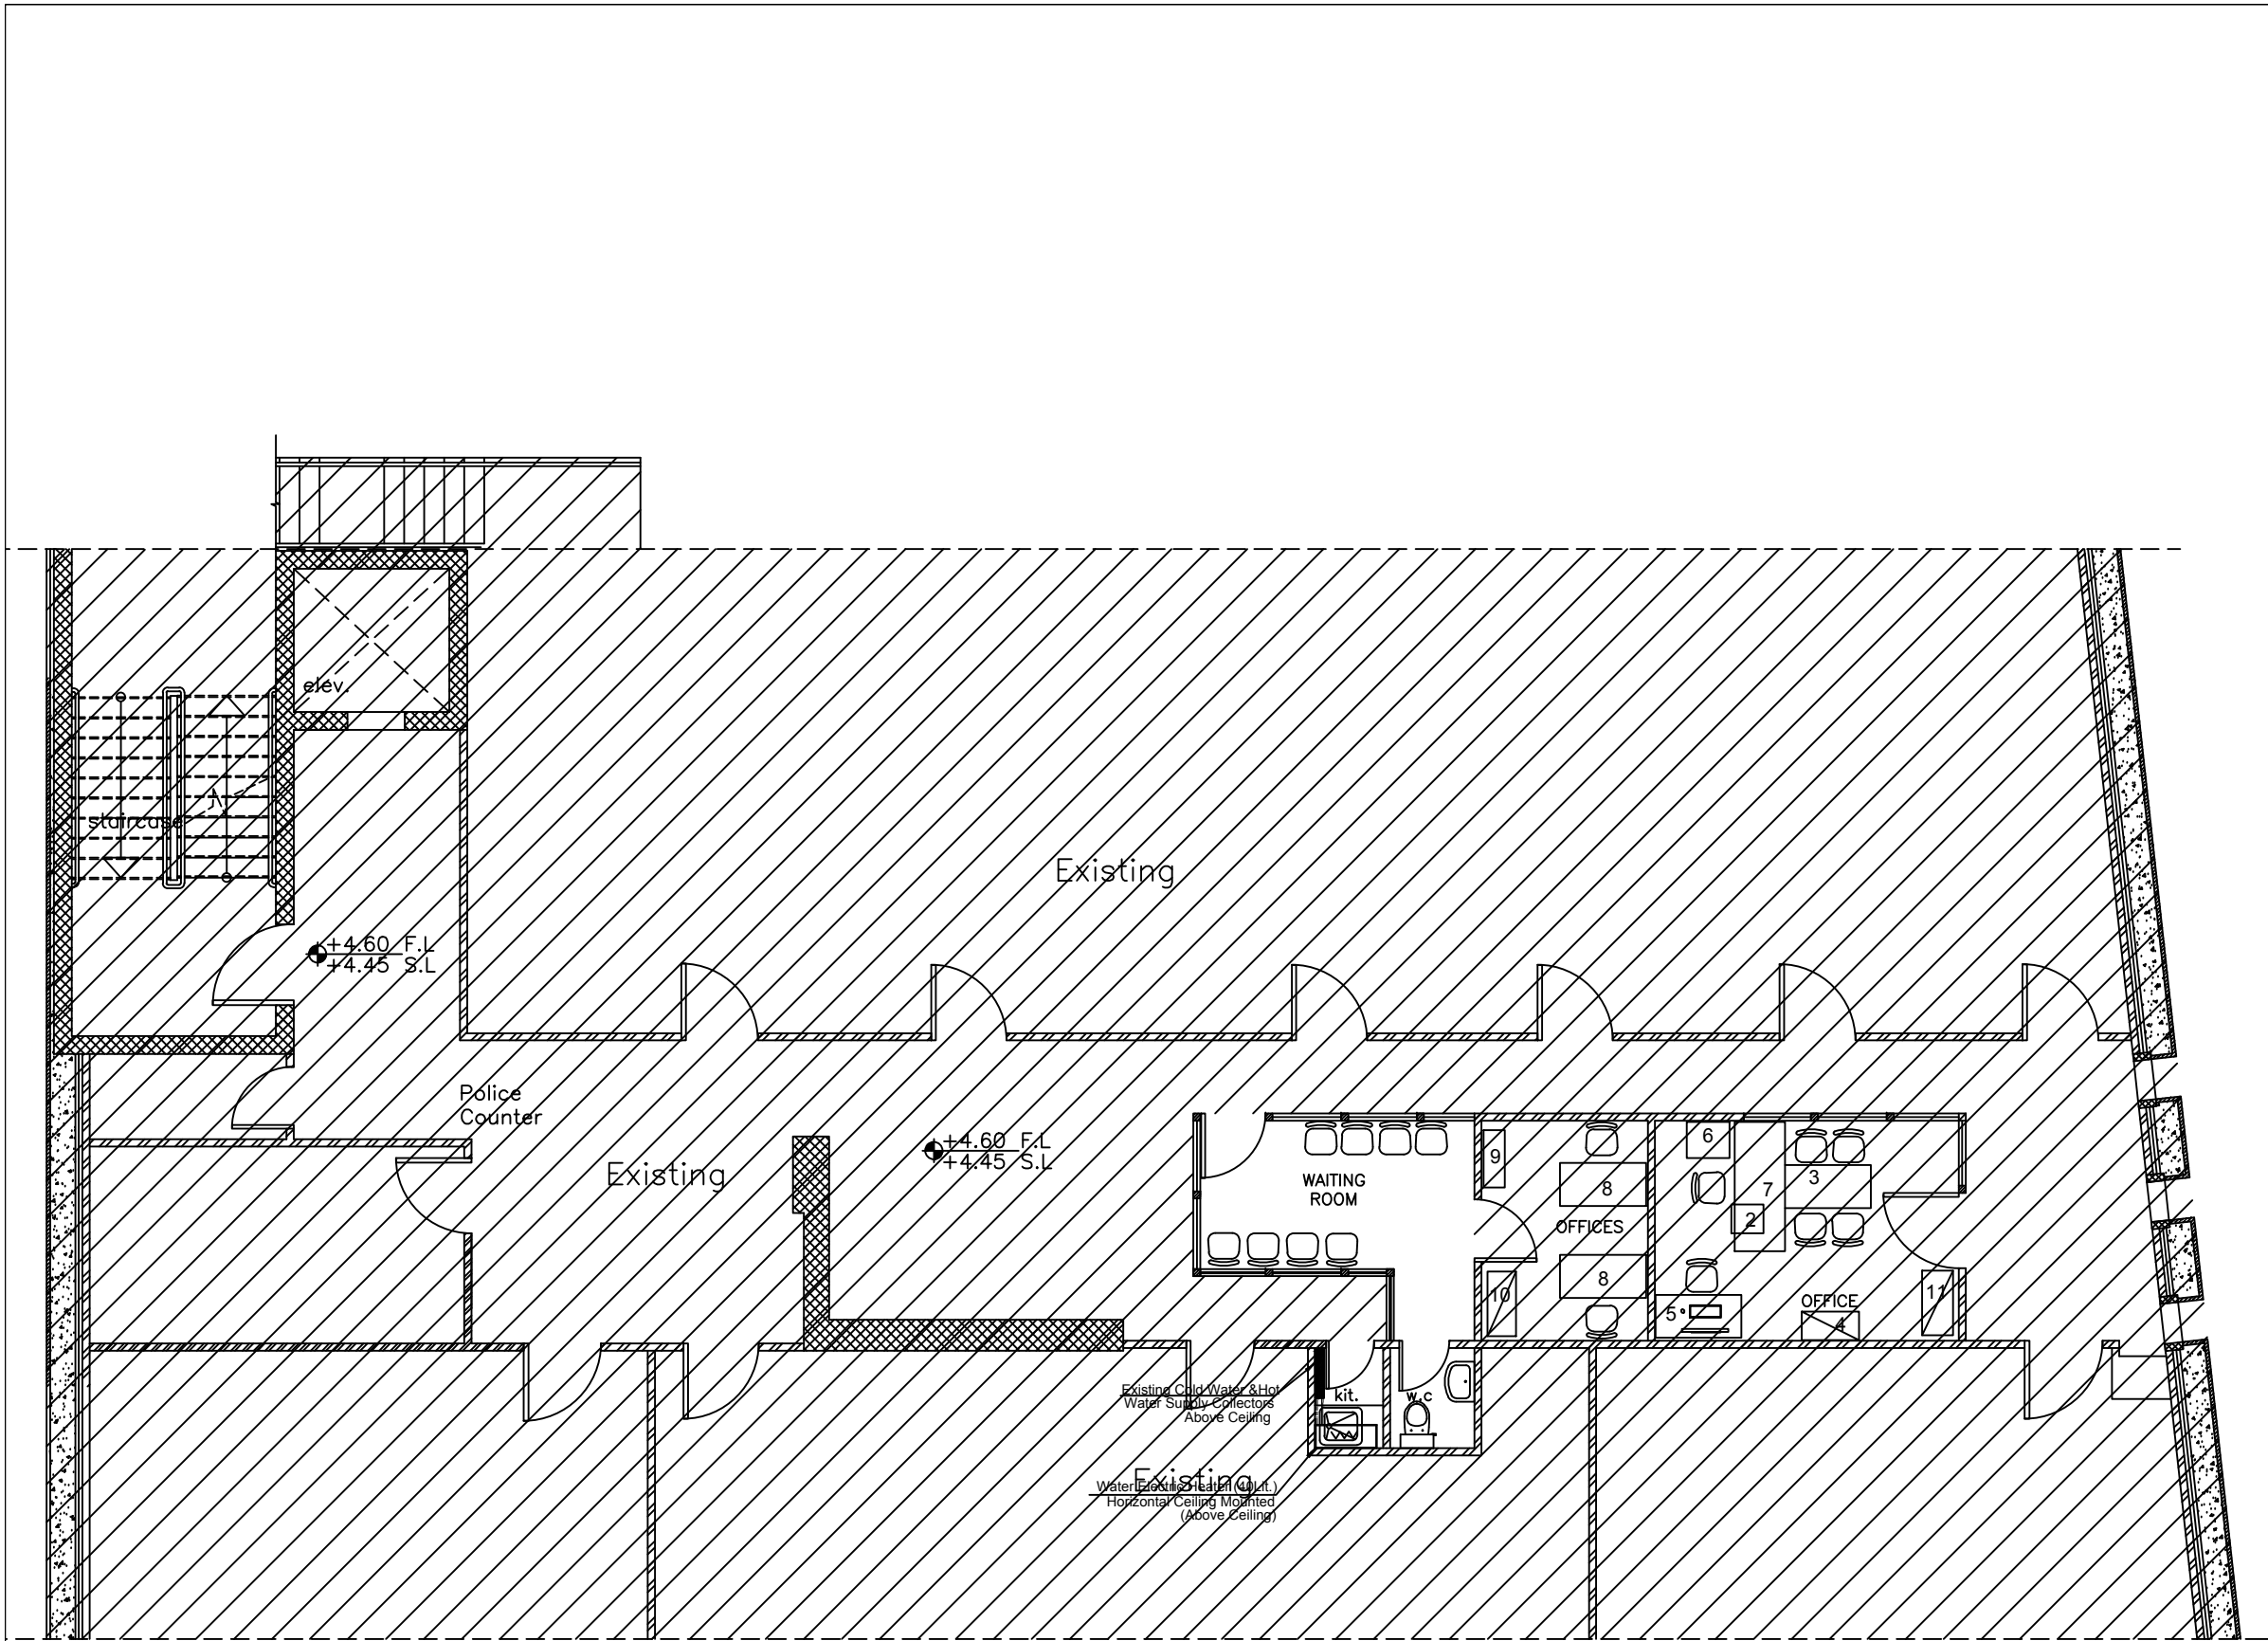

NOTES :

REVISION	DATE OF REVISION	INITIALS	REVISION DETAILS



ESTABLISH A SPECIALIZED COURT
IN NABLUS

PROJECT No. :

ISSUE : TENDER


DRAWING : **First Floor
Water System Layout**

	DRAWN : DIAMOND STAFF	APPROVED: DIAMOND STAFF	DATE: JUNE, 2021
	NO :	NO. :	
	CHECKED: DIAMOND STAFF	REF:	SCALE: 1/100
NO :			

SAFFARINI & ASSOCIATES
Ramallah
Fax 02-2959363
Tel 02-2987675

M201

Rev.: 2

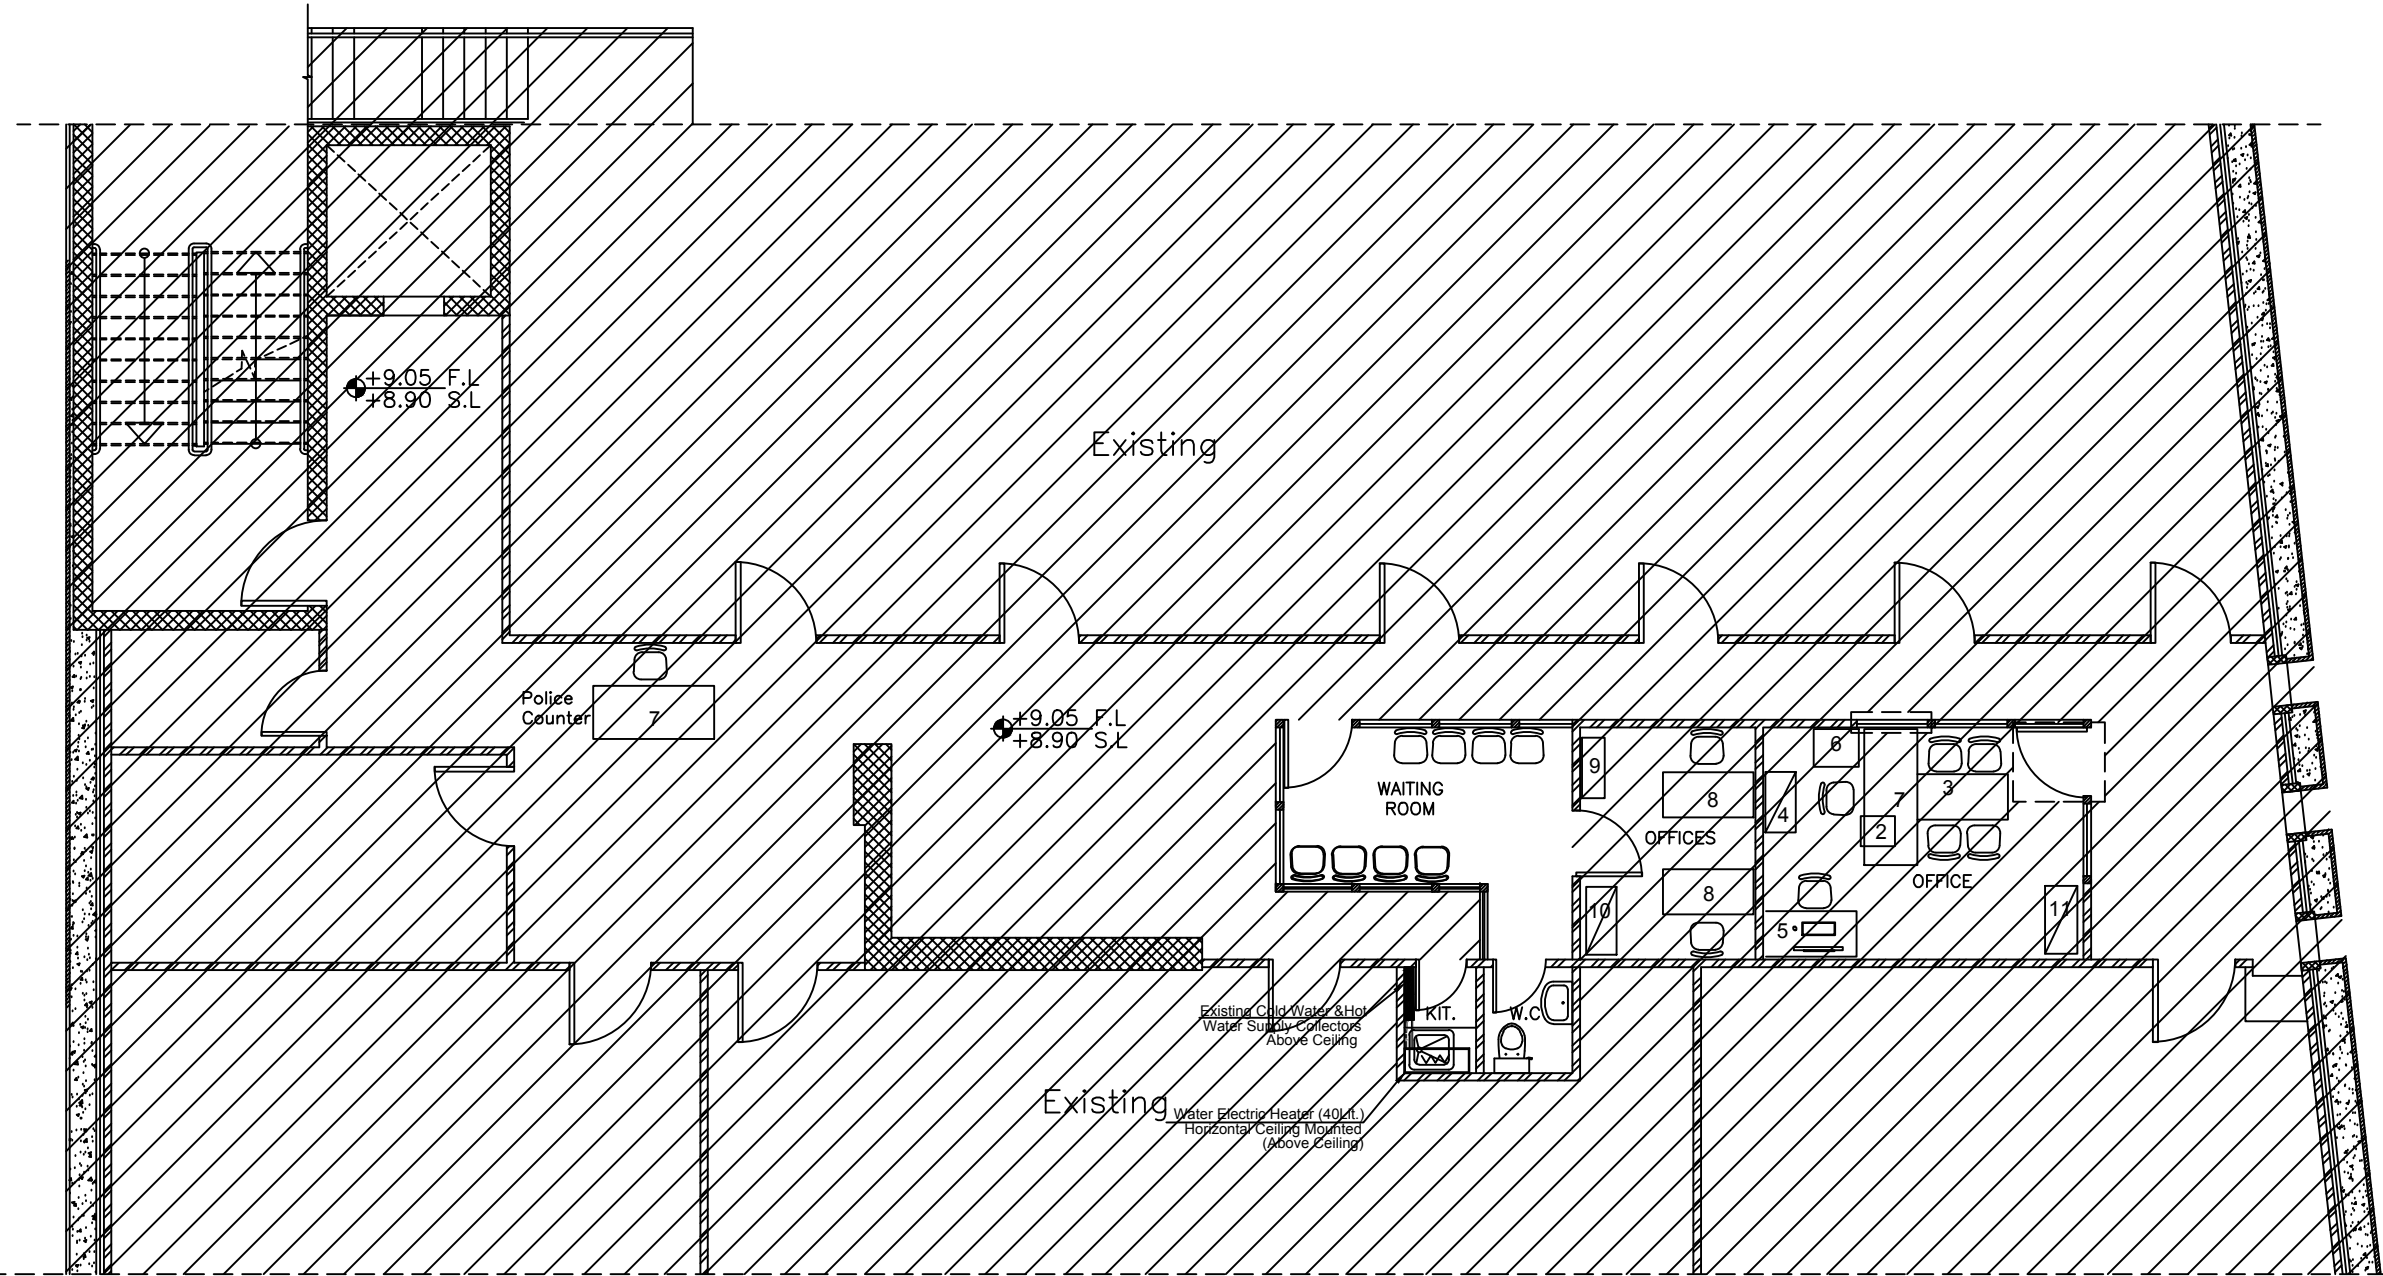

NOTES :

REVISION	DATE OF REVISION	INITIALS	REVISION DETAILS



ESTABLISH A SPECIALIZED COURT
IN NABLUS

PROJECT No. :

ISSUE : TENDER


DRAWING : **Second Floor
Water System Layout**

	DRAWN : DIAMOND STAFF	APPROVED: DIAMOND STAFF	DATE: JUNE, 2021
	NO :	NO. :	
	CHECKED: DIAMOND STAFF	REF:	
NO :			SCALE: 1/100

SAFFARINI & ASSOCIATES
Ramallah
Fax 02-2959363
Tel 02-2987675

M202

Rev.: 2

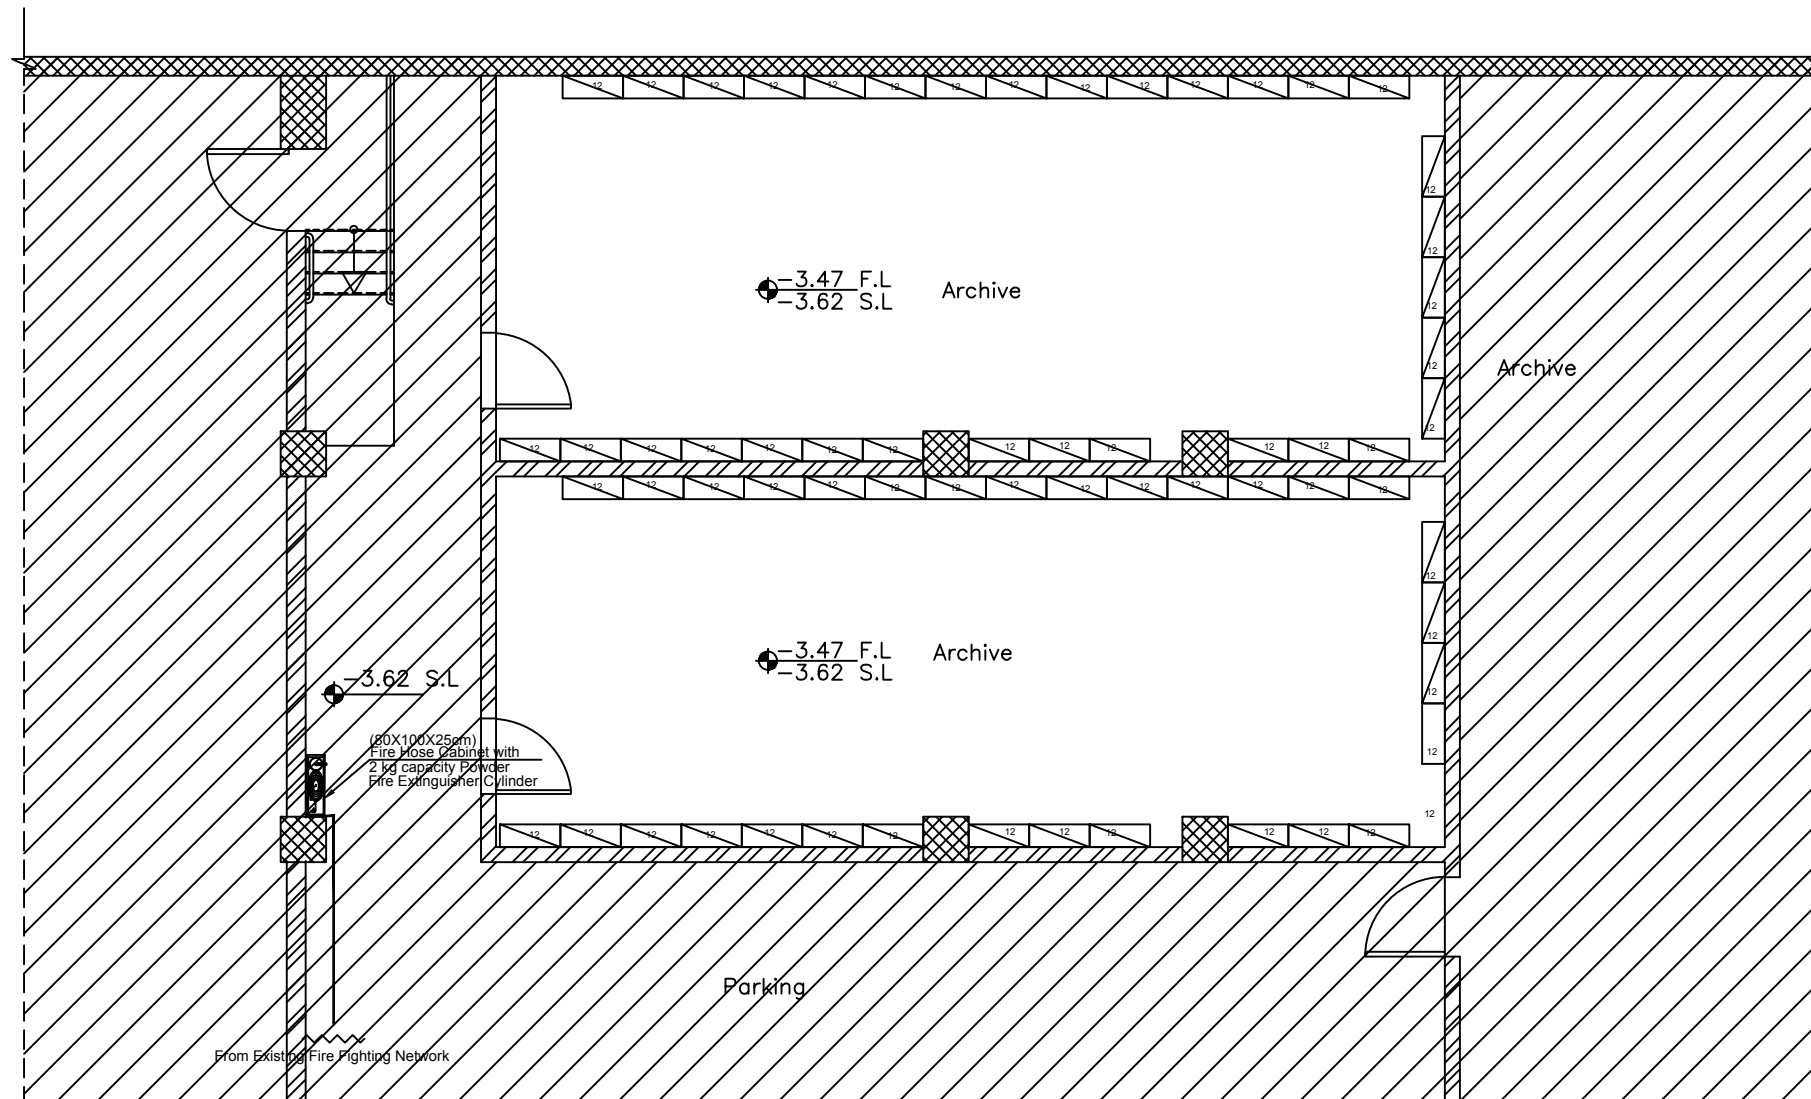

NOTES :

REVISION	DATE OF REVISION	INITIALS	REVISION DETAILS



ESTABLISH A SPECIALIZED COURT
IN NABLUS

PROJECT No. :

ISSUE : TENDER


DRAWING : **Parking Floor
Fire Fighting System Layout**

	DRAWN : DIAMOND STAFF	APPROVED: DIAMOND STAFF	DATE: JUNE, 2021
	NO :	NO. :	
	CHECKED: DIAMOND STAFF	REF:	SCALE: 1/100
	NO :		

SAFFARINI & ASSOCIATES
Ramallah
Fax 02-2959363
Tel 02-2987675

M301

Rev.: 2

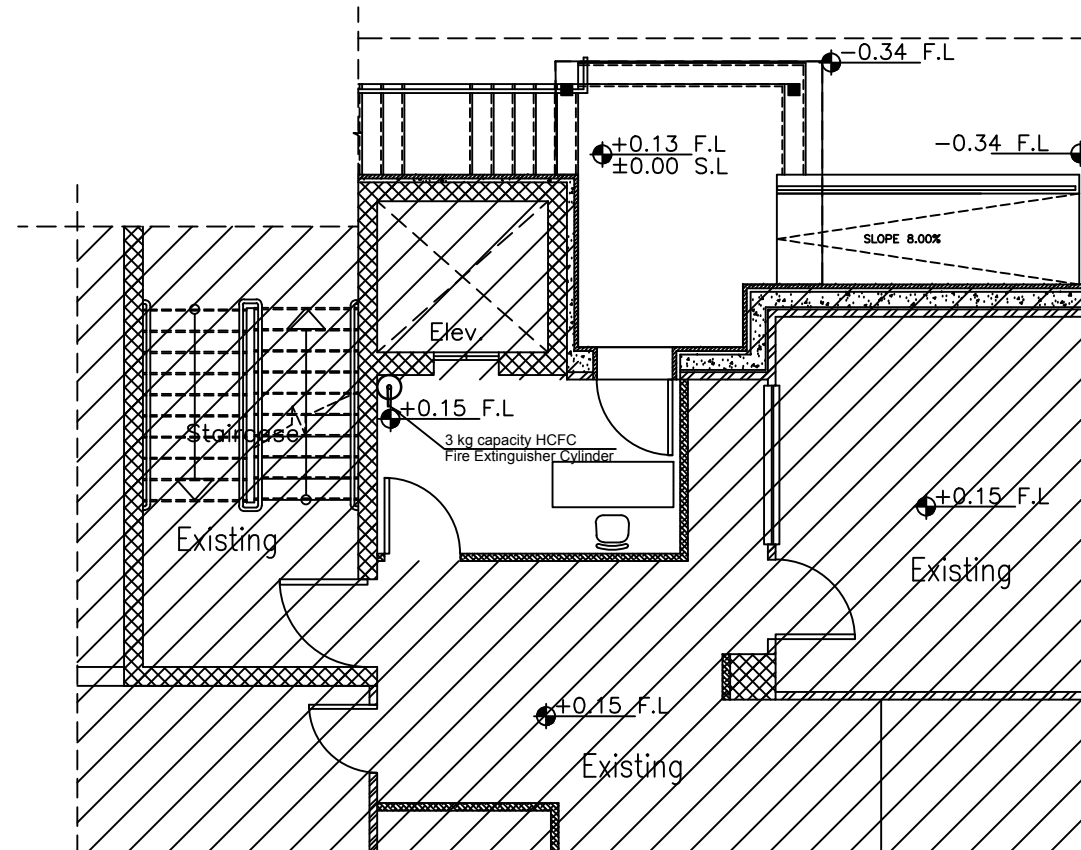

NOTES :

REVISION	DATE OF REVISION	INITIALS	REVISION DETAILS



ESTABLISH A SPECIALIZED COURT
IN NABLUS

PROJECT No. :

ISSUE : TENDER


DRAWING : **Ground Floor
Fire Fighting System Layout**

	DRAWN : DIAMOND STAFF	APPROVED: DIAMOND STAFF	DATE: JUNE, 2021
	NO :	NO. :	
	CHECKED: DIAMOND STAFF	REF:	SCALE: 1/100
	NO :		

SAFFARINI & ASSOCIATES
Ramallah
Fax 02-2959363
Tel 02-2987675

M302

Rev.: 2

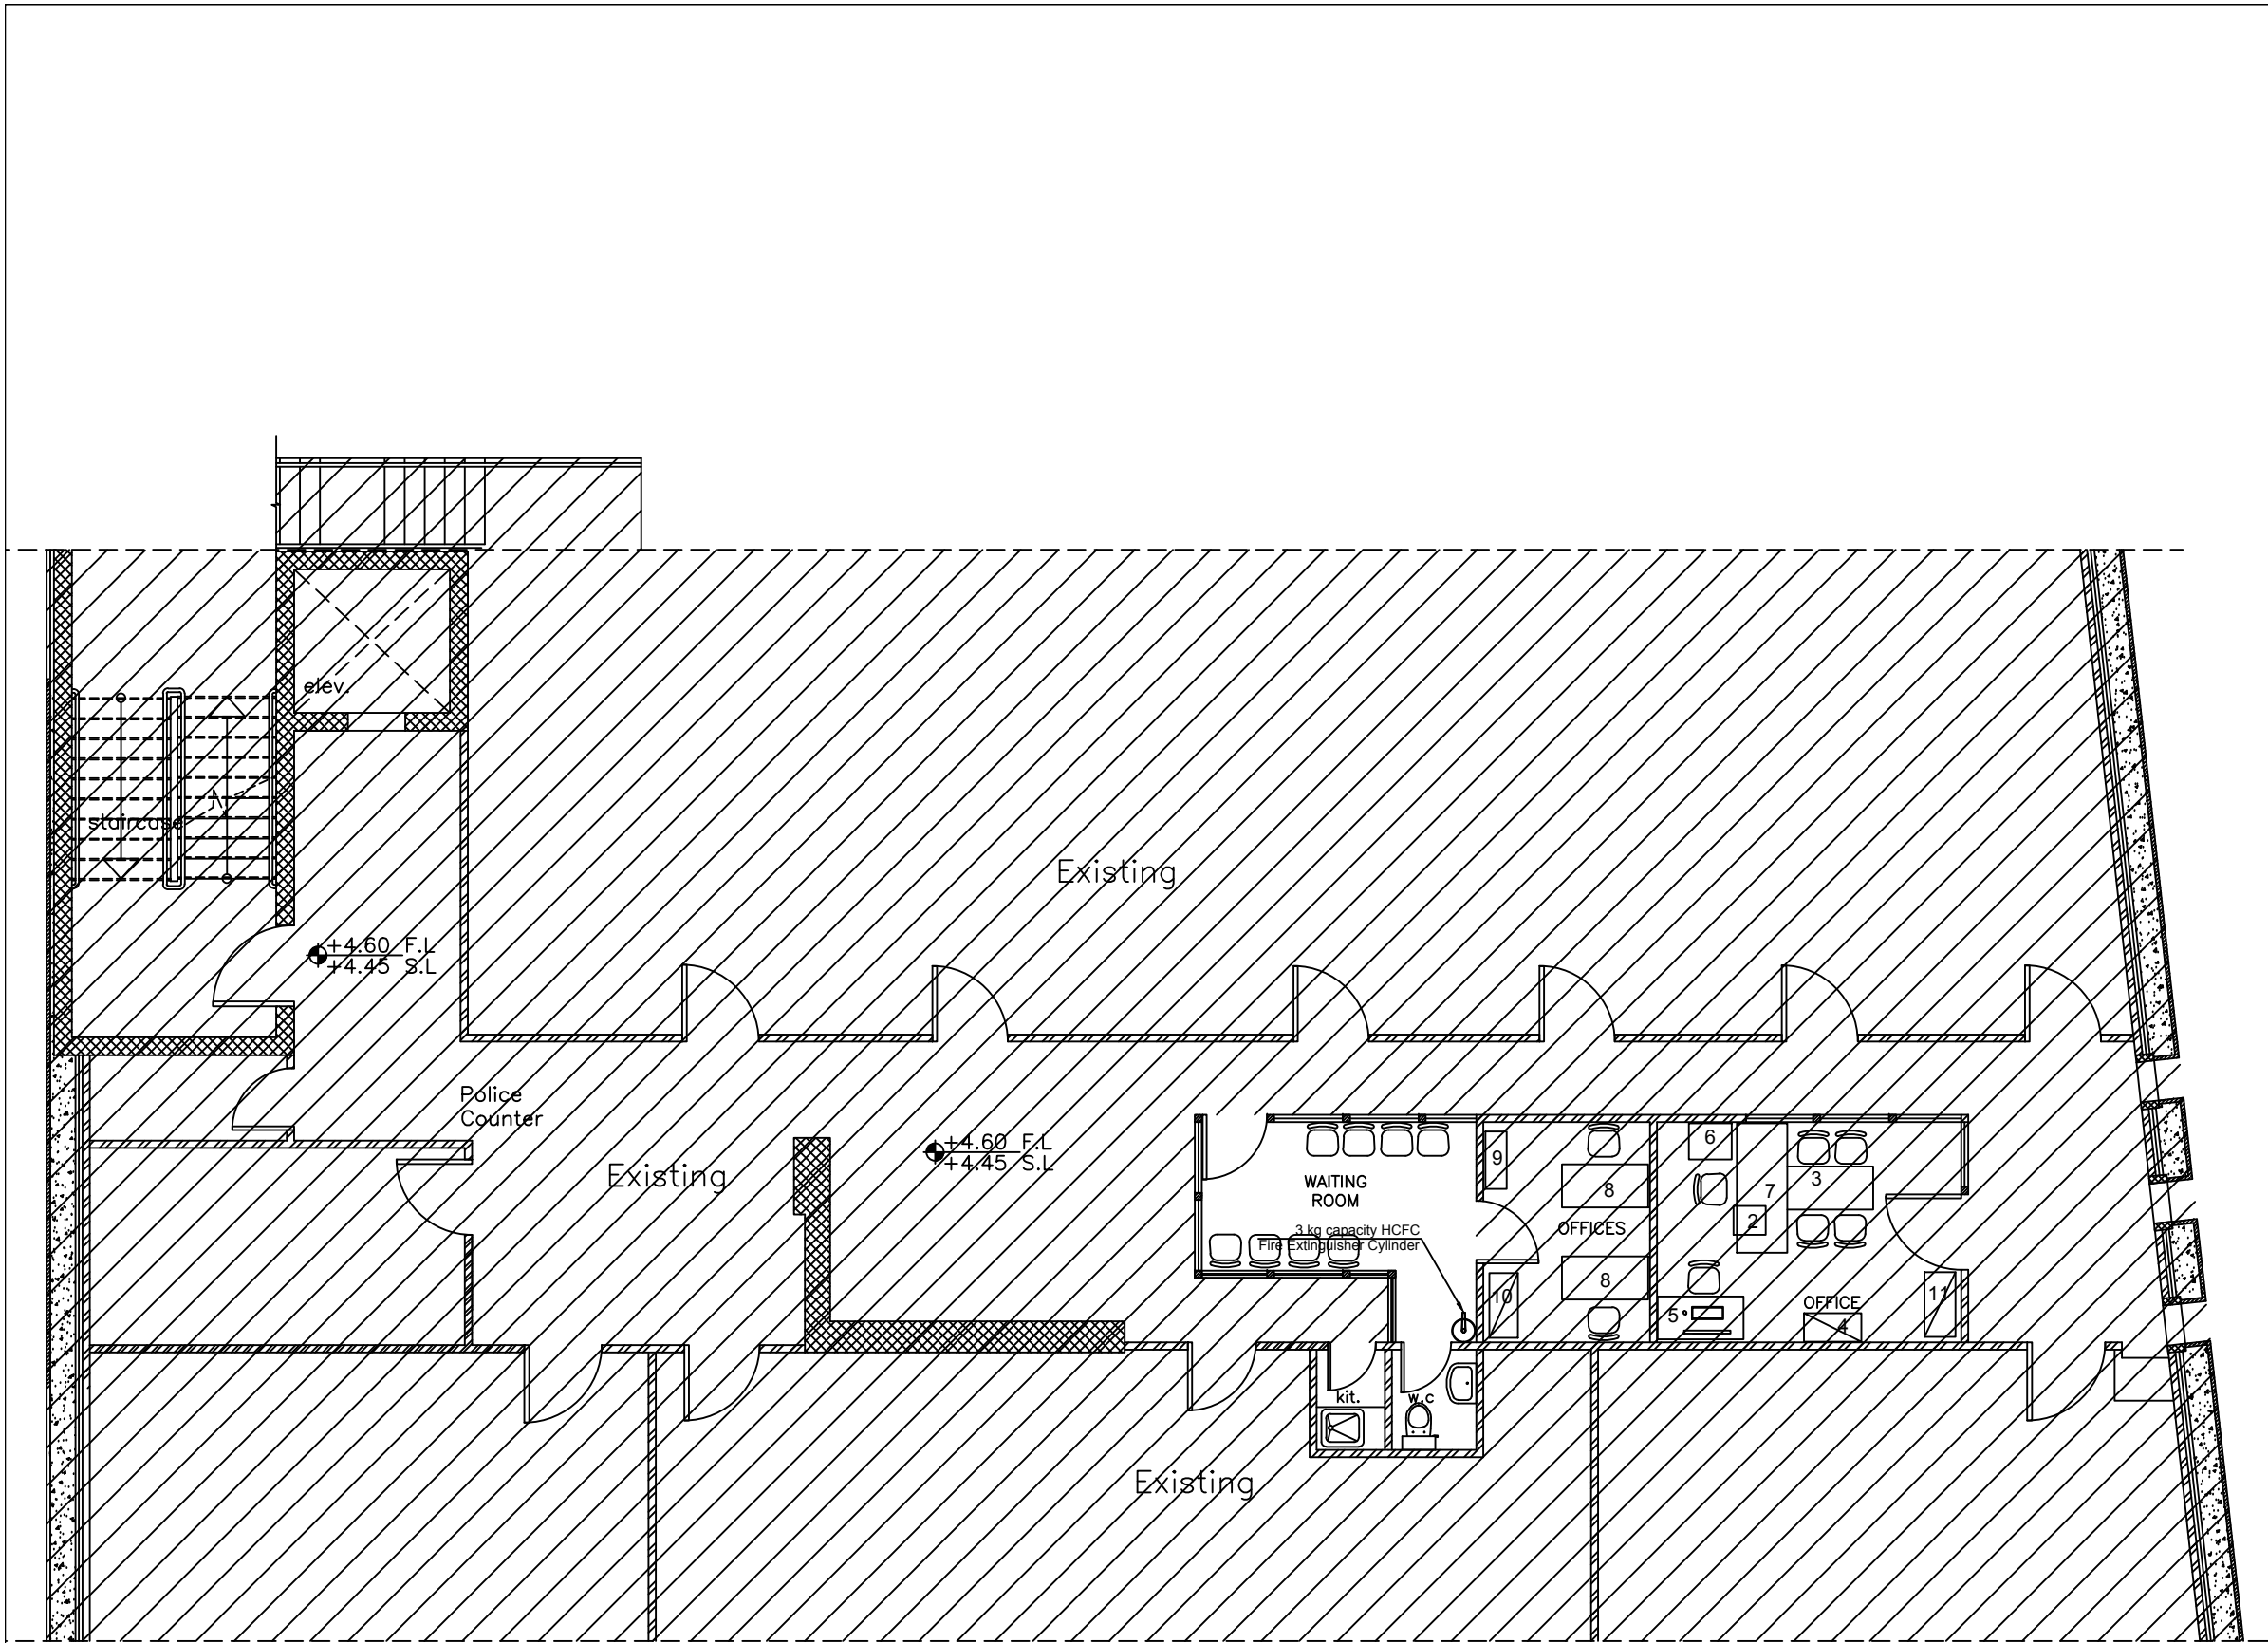

NOTES :

REVISION	DATE OF REVISION	INITIALS	REVISION DETAILS



ESTABLISH A SPECIALIZED COURT
IN NABLUS

PROJECT No. :

ISSUE : TENDER


DRAWING : **First Floor
Fire Fighting System Layout**

	DRAWN : DIAMOND STAFF	APPROVED: DIAMOND STAFF	DATE: JUNE, 2021
	NO :	NO. :	
	CHECKED: DIAMOND STAFF	REF:	SCALE: 1/100
	NO :		

SAFFARINI & ASSOCIATES
Ramallah
Fax 02-2959363
Tel 02-2987675

M303

Rev.: 2

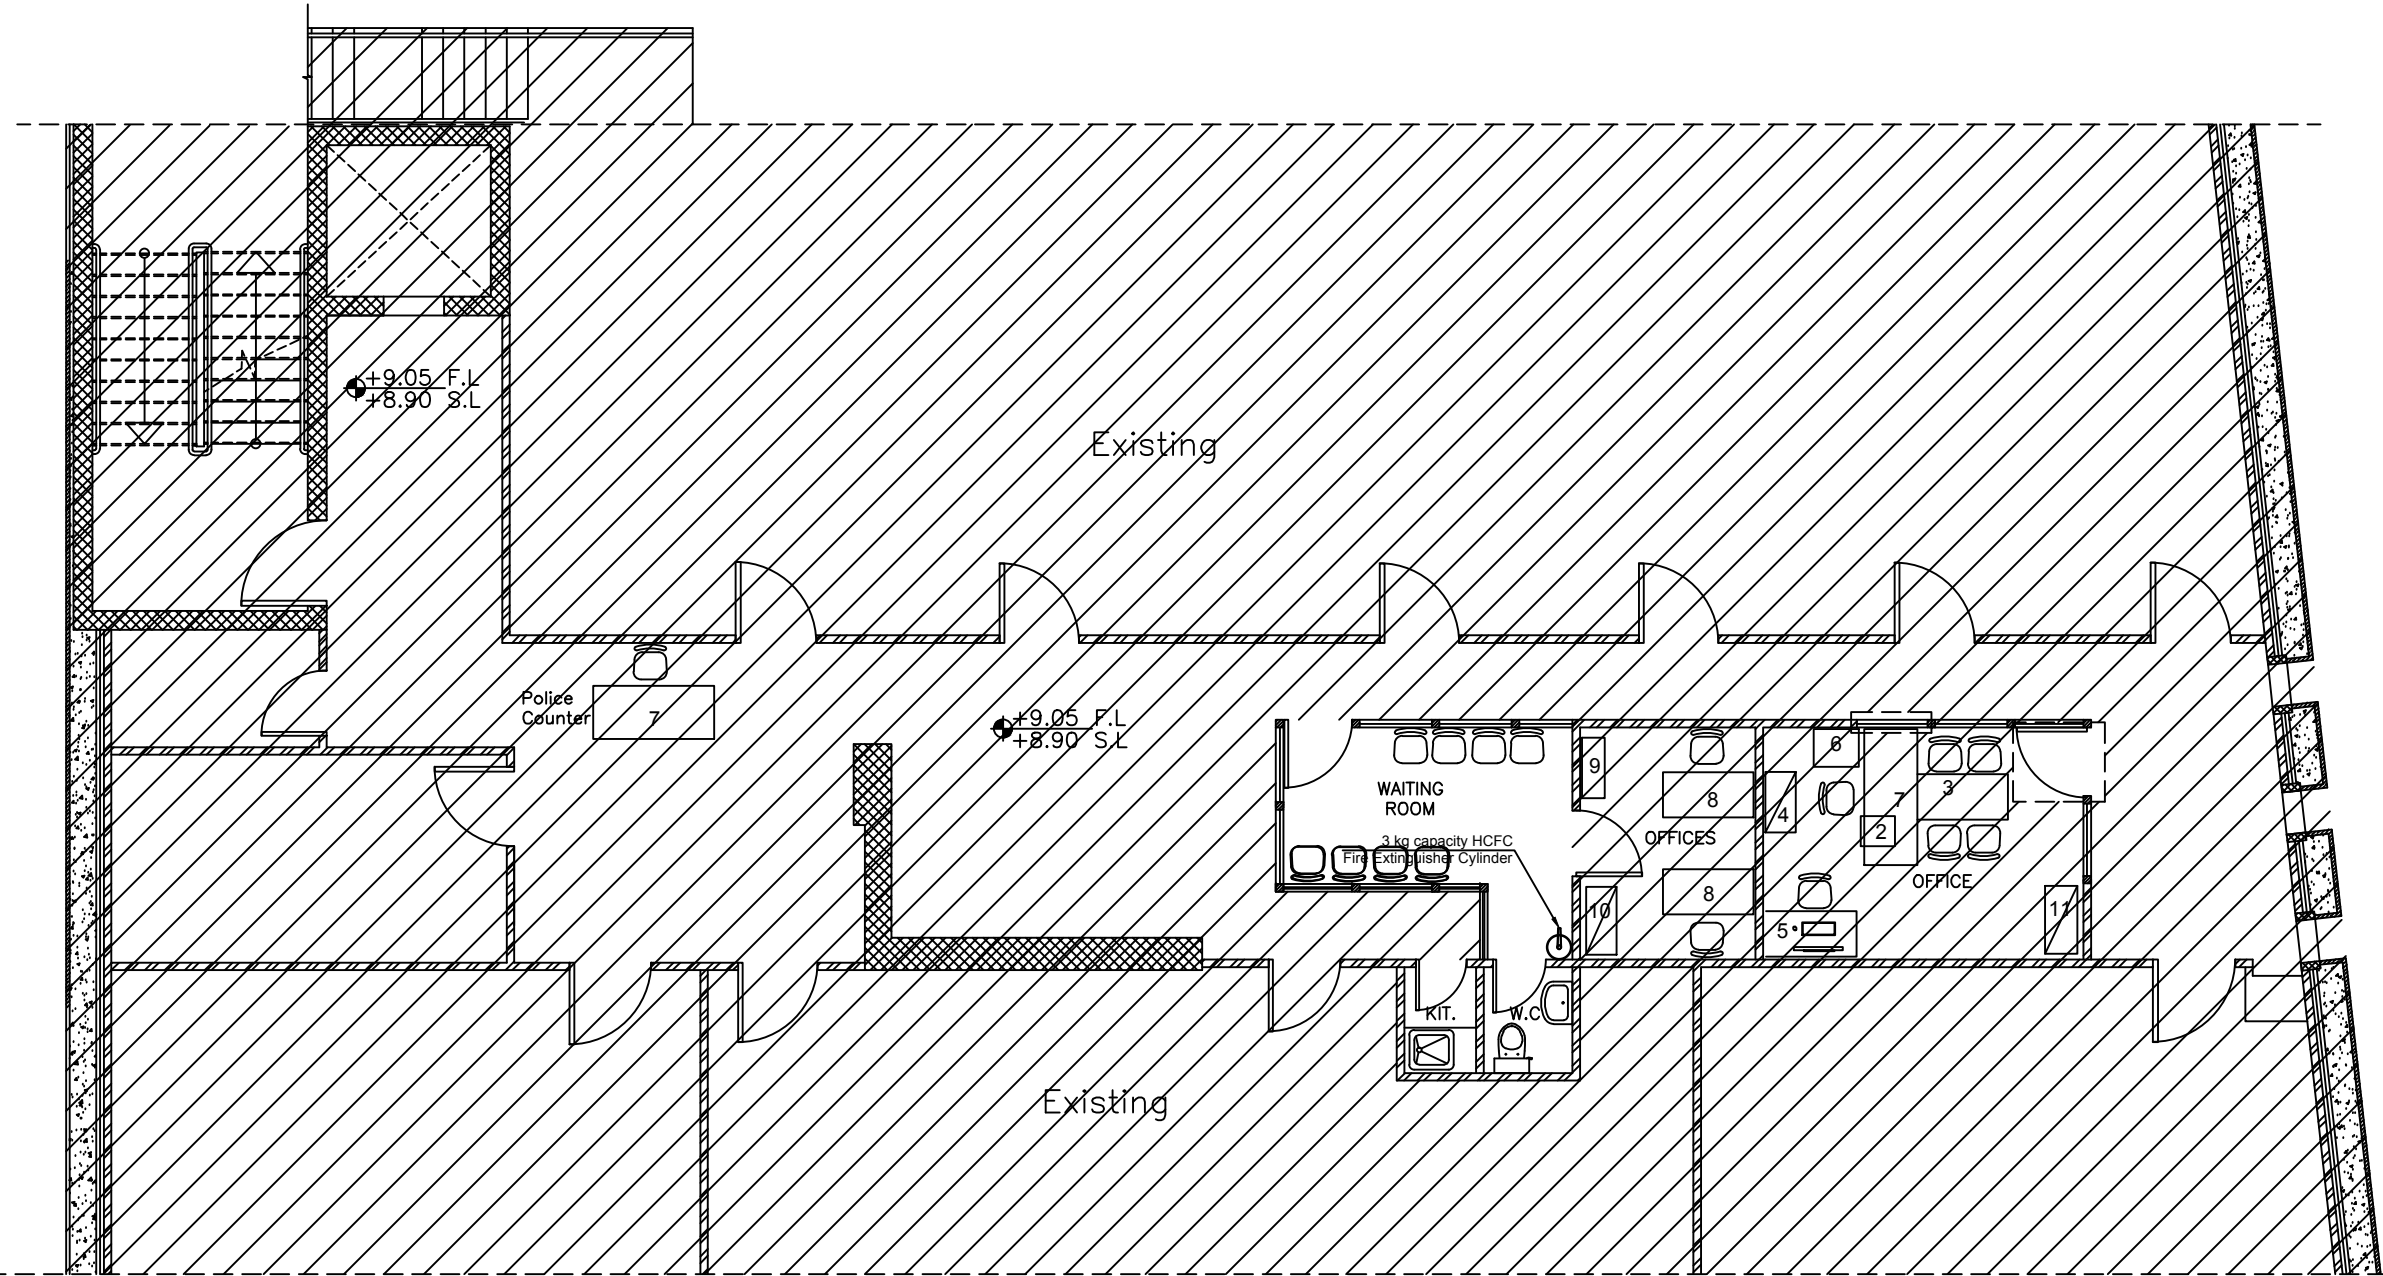

NOTES :

REVISION	DATE OF REVISION	INITIALS	REVISION DETAILS



ESTABLISH A SPECIALIZED COURT
IN NABLUS

PROJECT No. :

ISSUE : TENDER


DRAWING : **Second Floor**
Fire Fighting System Layout

	DRAWN : DIAMOND STAFF	APPROVED: DIAMOND STAFF	DATE: JUNE, 2021
	NO :	NO. :	
	CHECKED: DIAMOND STAFF	REF:	SCALE: 1/100
	NO :		

SAFFARINI & ASSOCIATES
Ramallah
Fax 02-2959363
Tel 02-2987675

M304

Rev.: 2

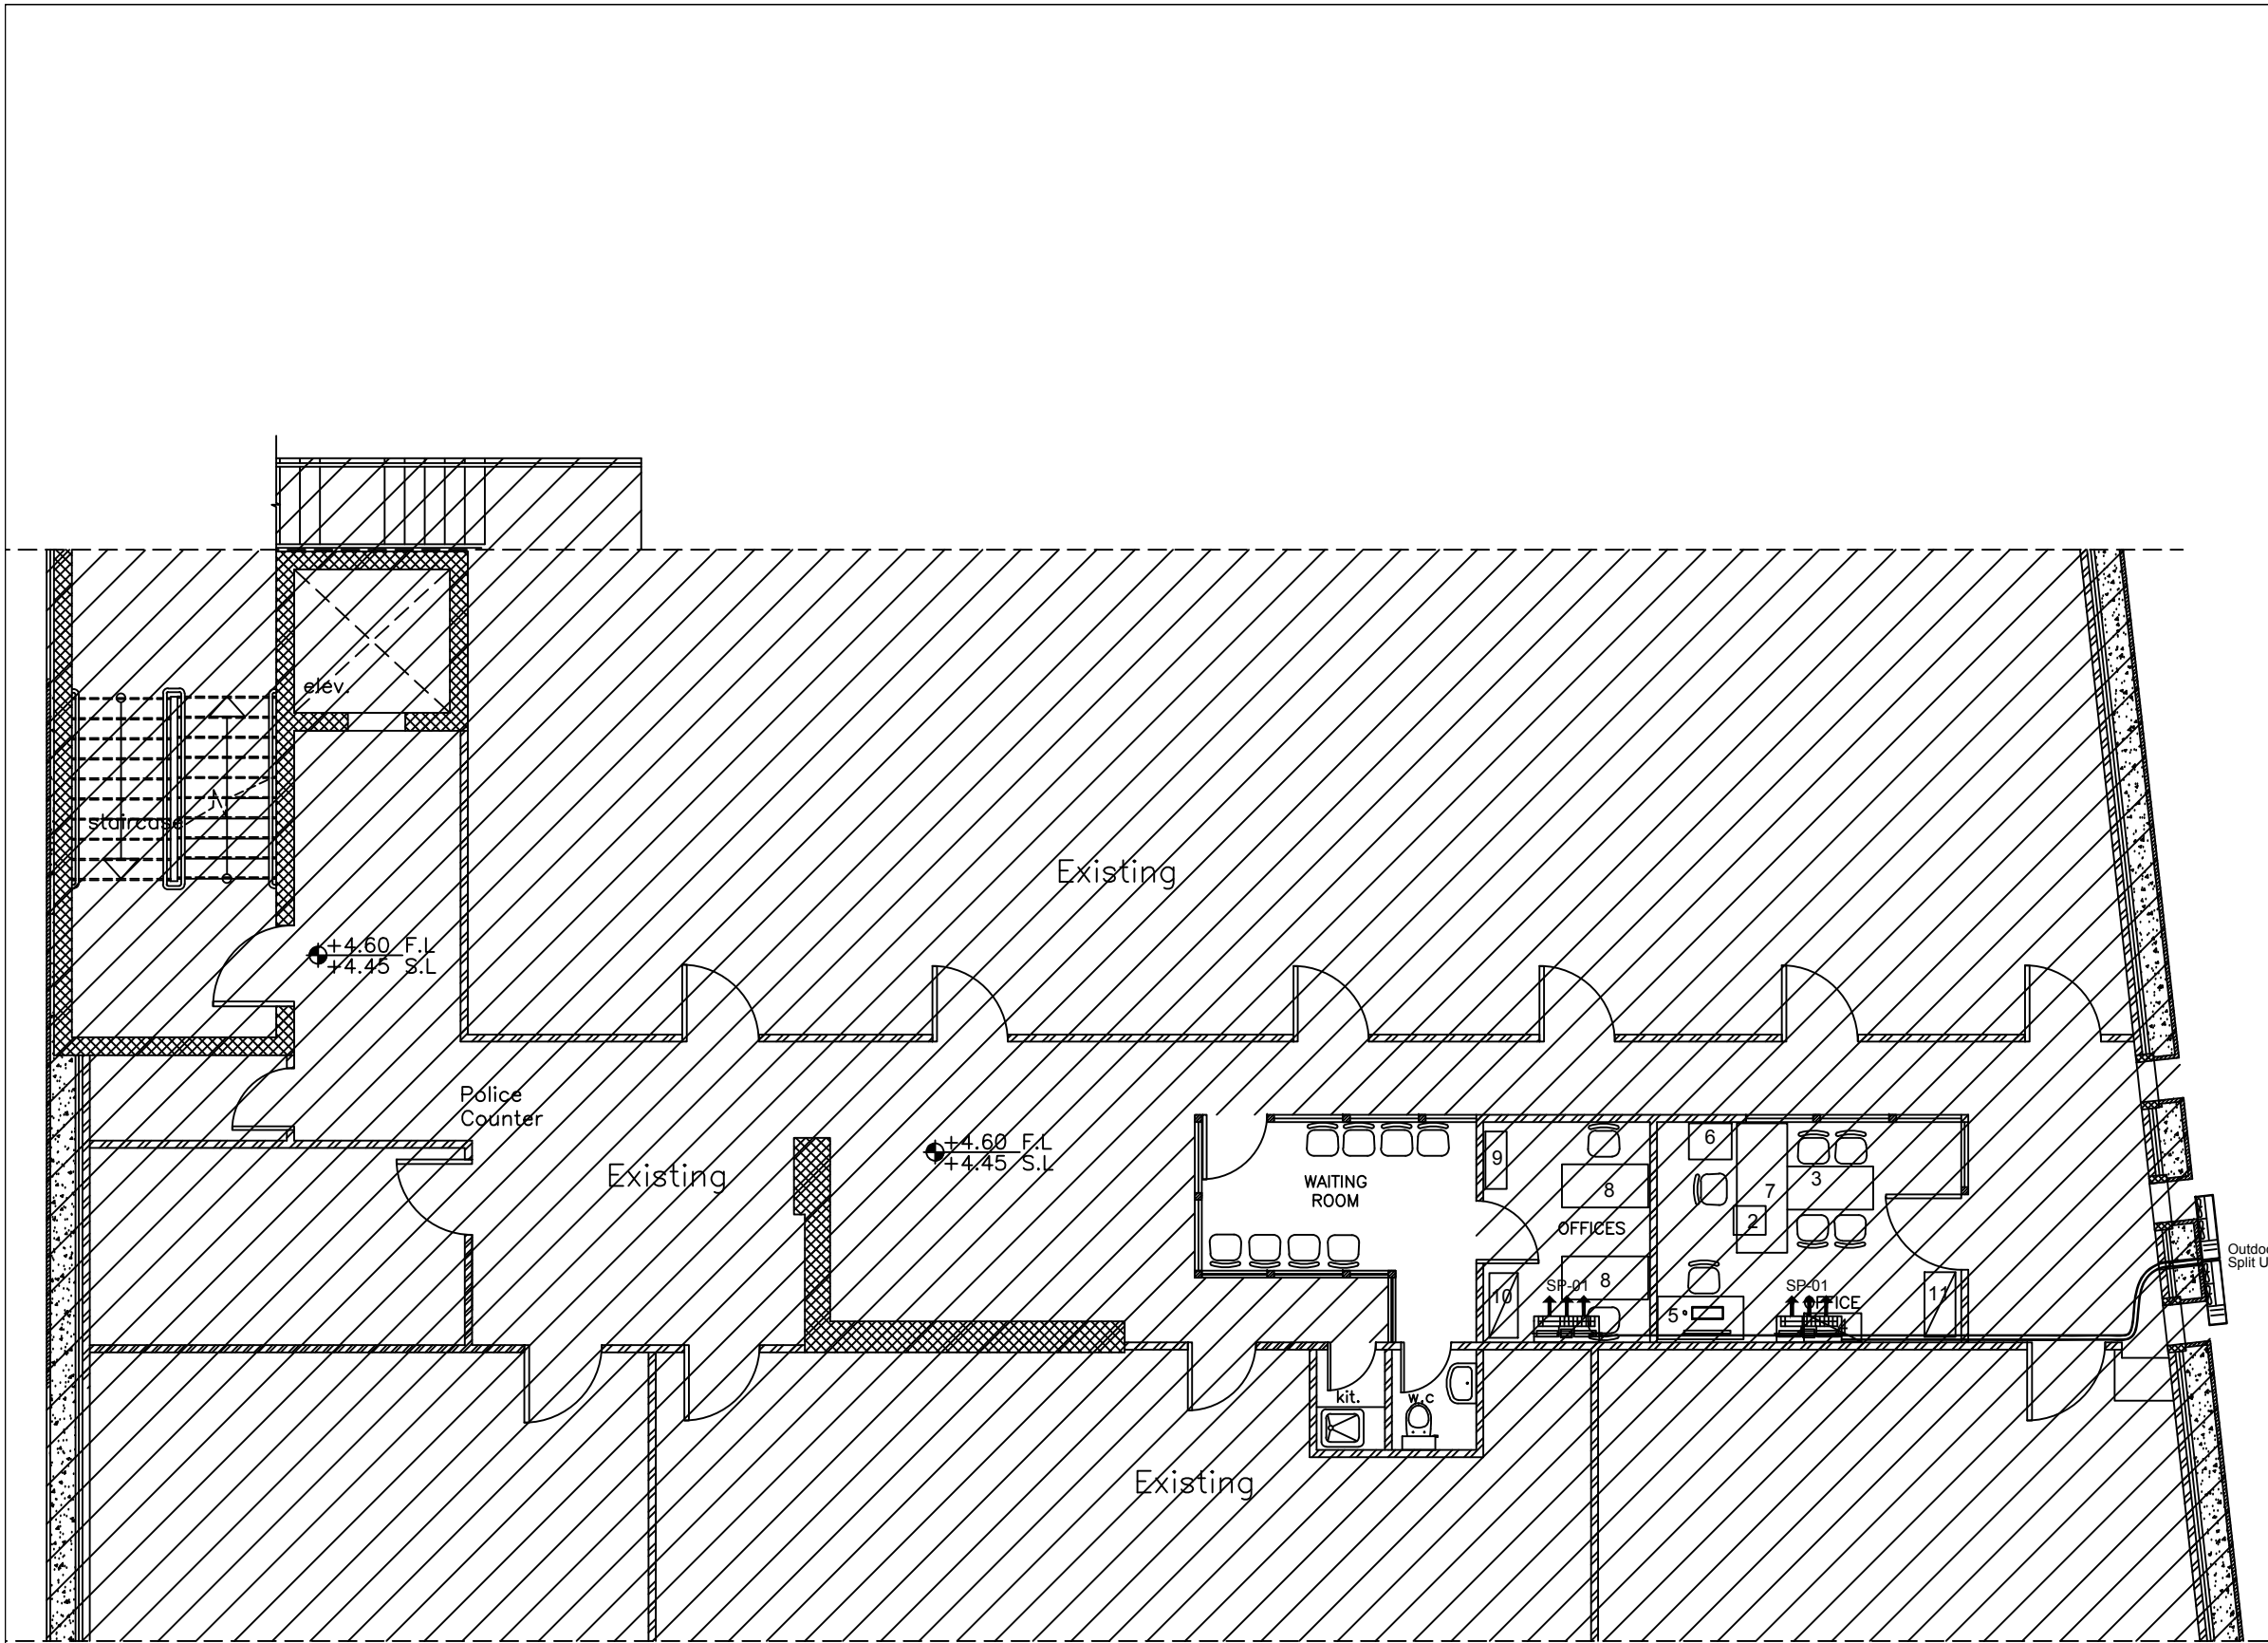

NOTES :

REVISION	DATE OF REVISION	INITIALS	REVISION DETAILS





ESTABLISH A SPECIALIZED COURT
IN NABLUS

PROJECT No. :


ISSUE : TENDER

First Floor
DRAWING : Air Conditioning System Layout

	DRAWN : DIAMOND STAFF NO. :	APPROVED: DIAMOND STAFF NO. :	DATE: JUNE, 2021
	CHECKED: DIAMOND STAFF NO. :	REF:	SCALE: 1/100

SAFFARINI & ASSOCIATES
Ramallah
Fax 02-2959363
Tel 02-2987675

M401
Rev.: 2

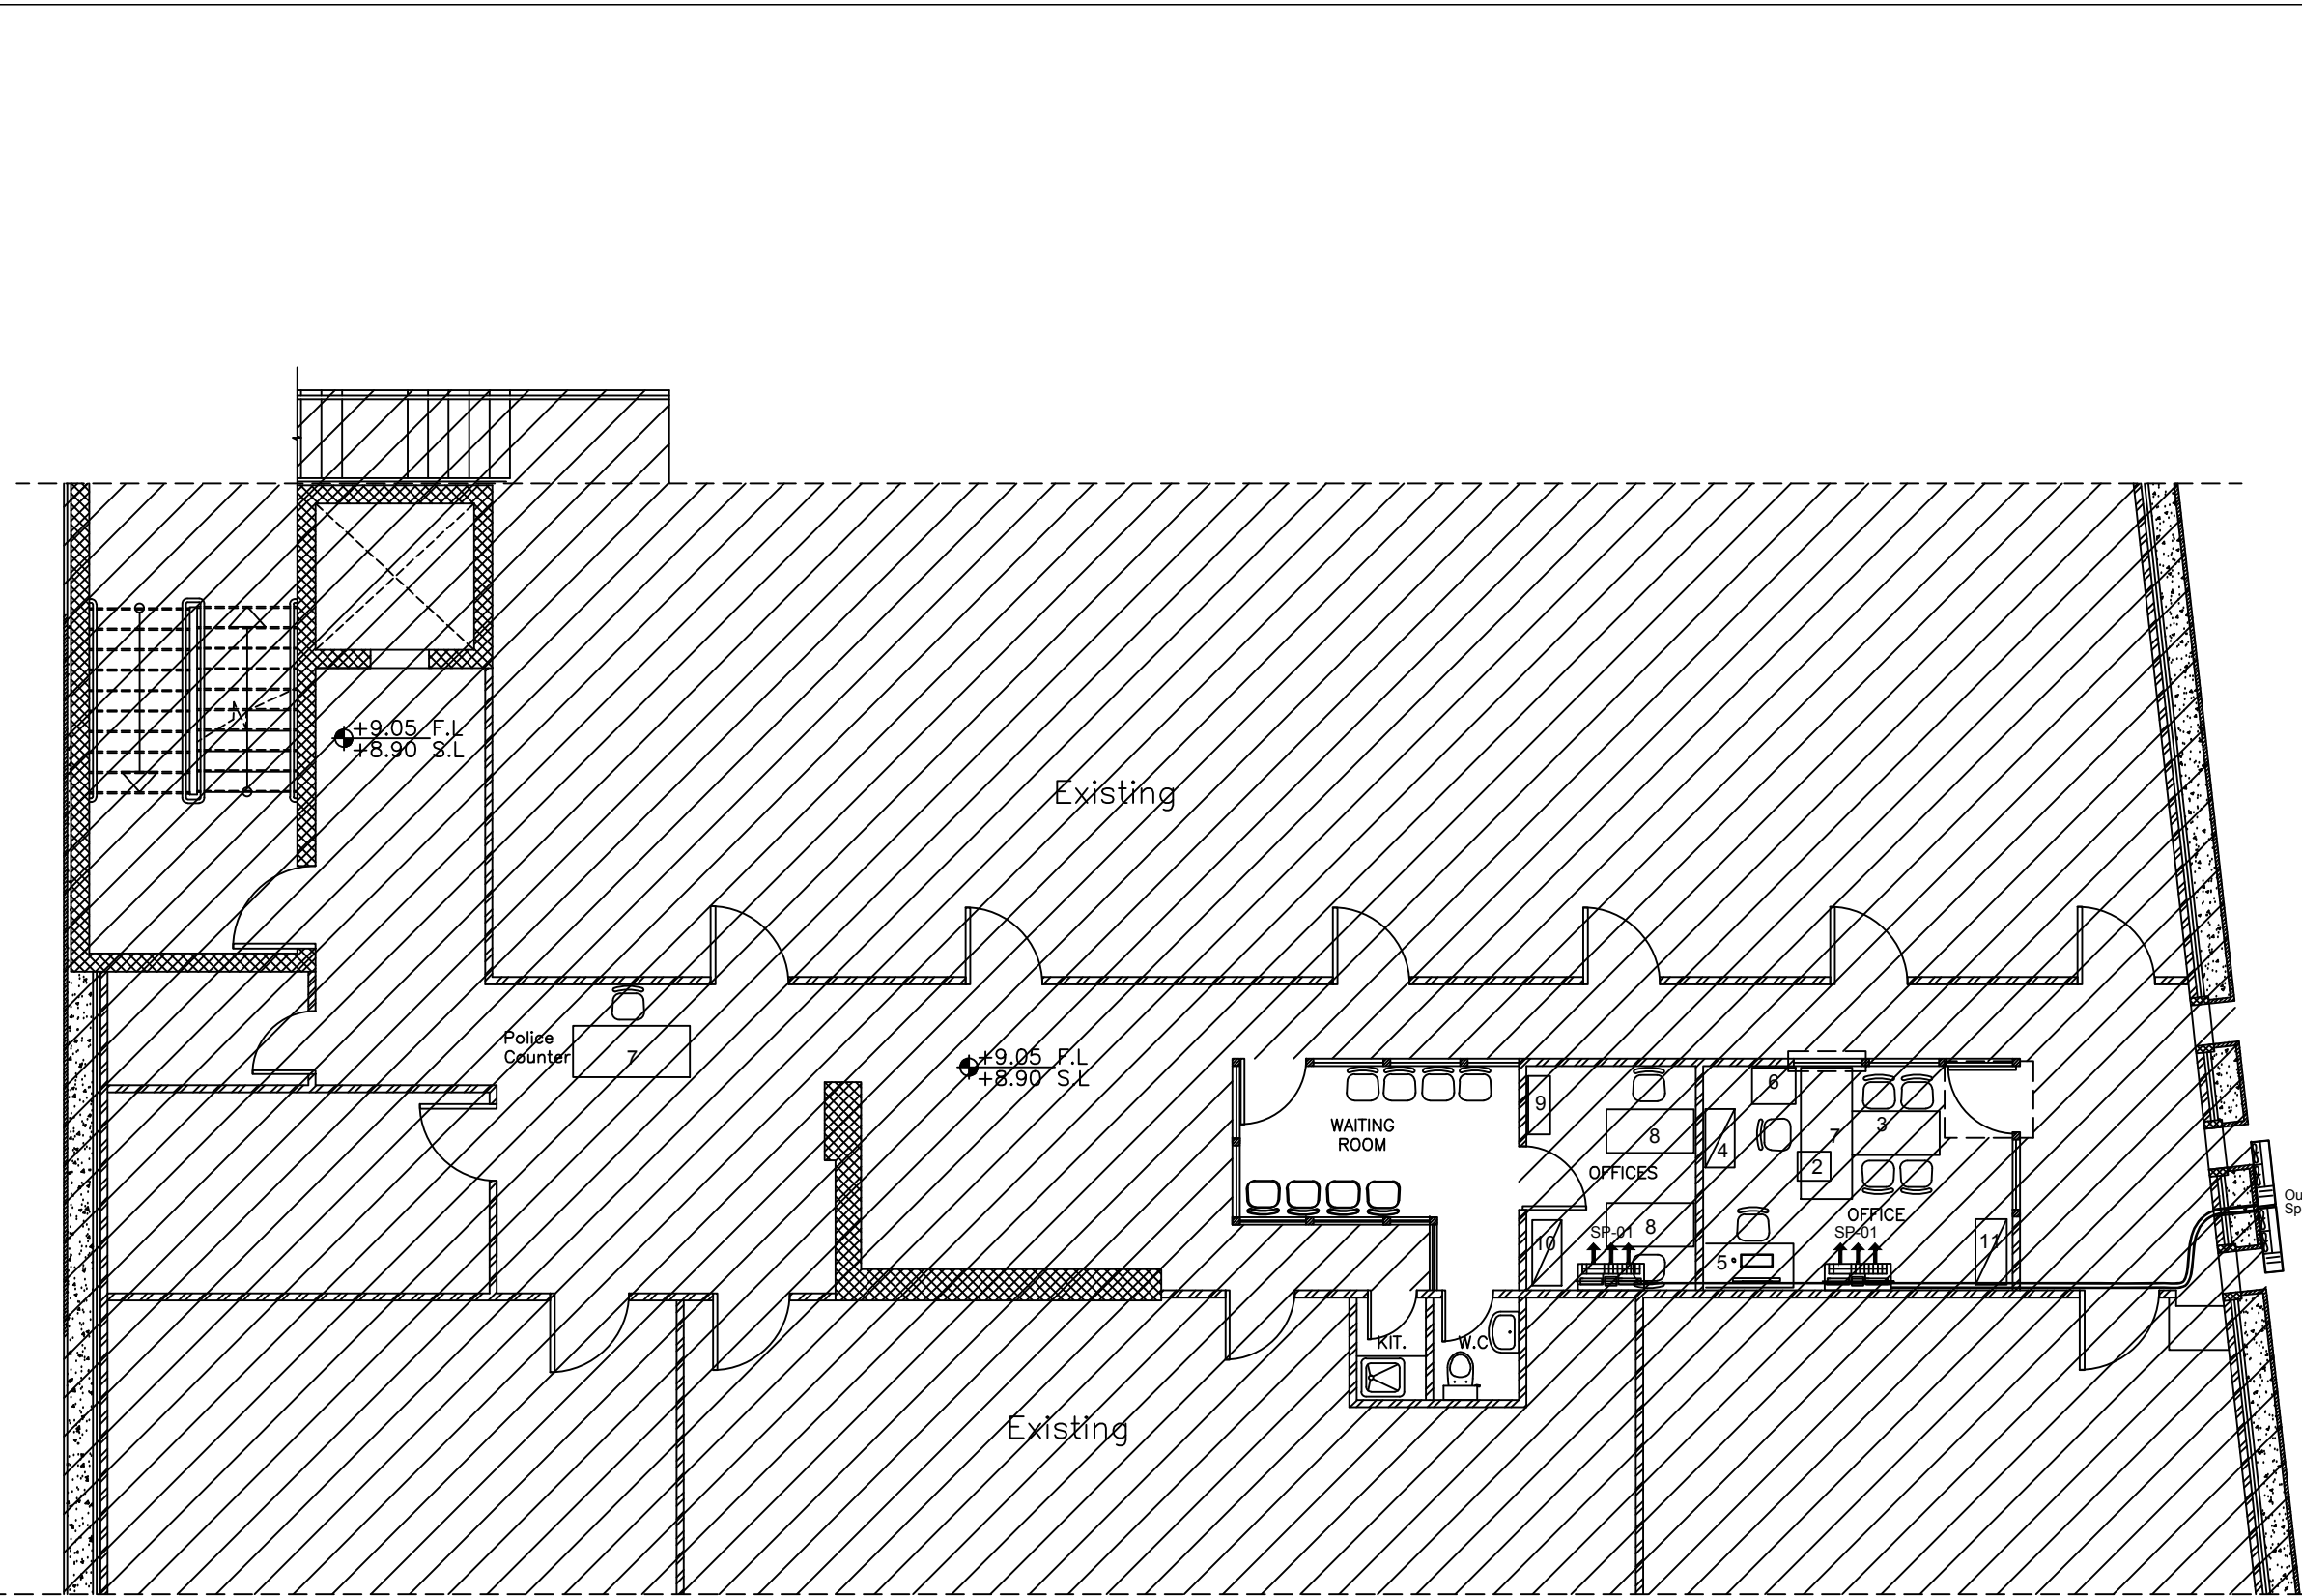

NOTES :

REVISION	DATE OF REVISION	INITIALS	REVISION DETAILS



ESTABLISH A SPECIALIZED COURT
IN NABLUS

PROJECT No. :

ISSUE : TENDER


Second Floor
DRAWING : Air Conditioning System Layout

	DRAWN : DIAMOND STAFF	APPROVED: DIAMOND STAFF	DATE: JUNE, 2021
	NO :	NO. :	
	CHECKED: DIAMOND STAFF	REF:	SCALE: 1/100
NO :			

SAFFARINI & ASSOCIATES
Ramallah
Fax 02-2959363
Tel 02-2987675

M402

Rev.: 2

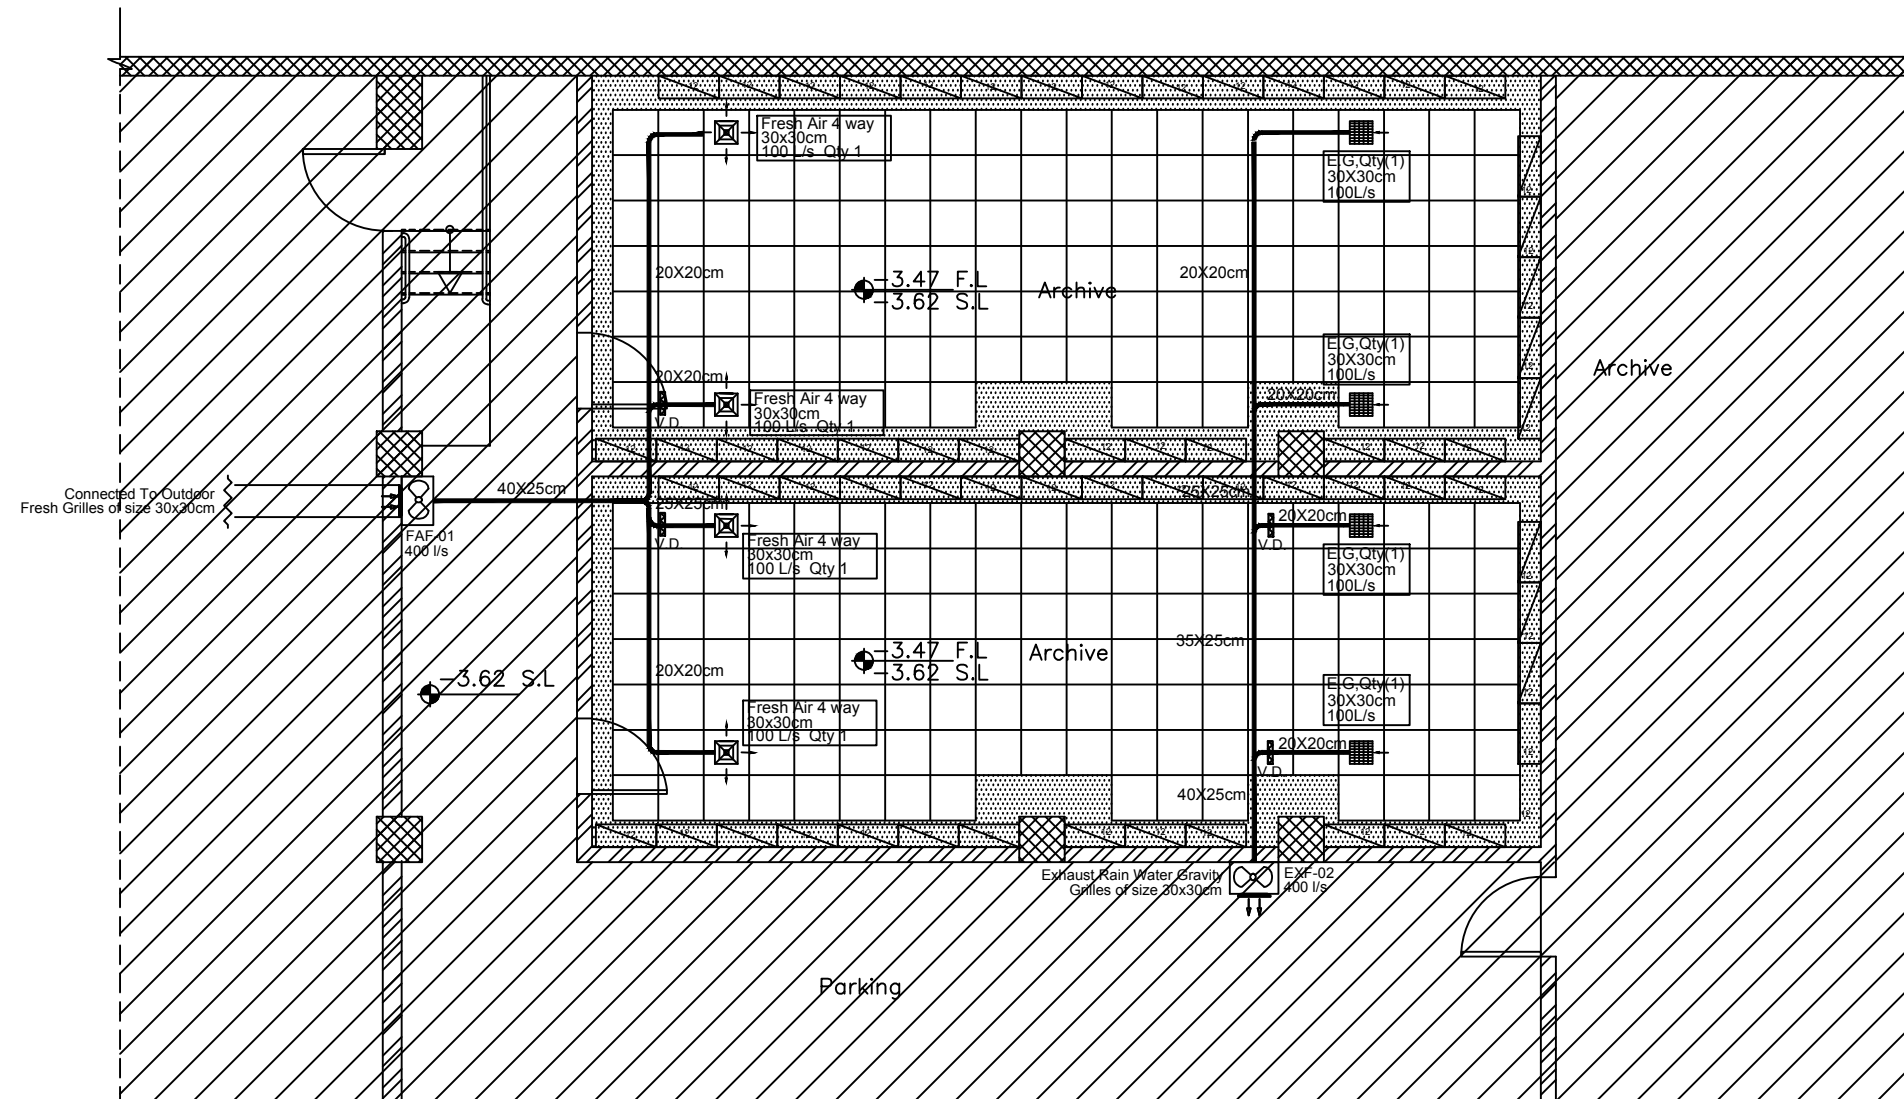

NOTES :

REVISION	DATE OF REVISION	INITIALS	REVISION DETAILS



ESTABLISH A SPECIALIZED COURT
IN NABLUS

PROJECT No. :

ISSUE : TENDER


DRAWING : **Parking Floor
Ventilation System Layout**

	DRAWN : DIAMOND STAFF	APPROVED: DIAMOND STAFF	DATE: JUNE, 2021
	NO. :	NO. :	
	CHECKED: DIAMOND STAFF	REF:	
NO. :			SCALE: 1/100

SAFFARINI & ASSOCIATES
Ramallah
Fax 02-2959363
Tel 02-2987675

M501

Rev.: 2

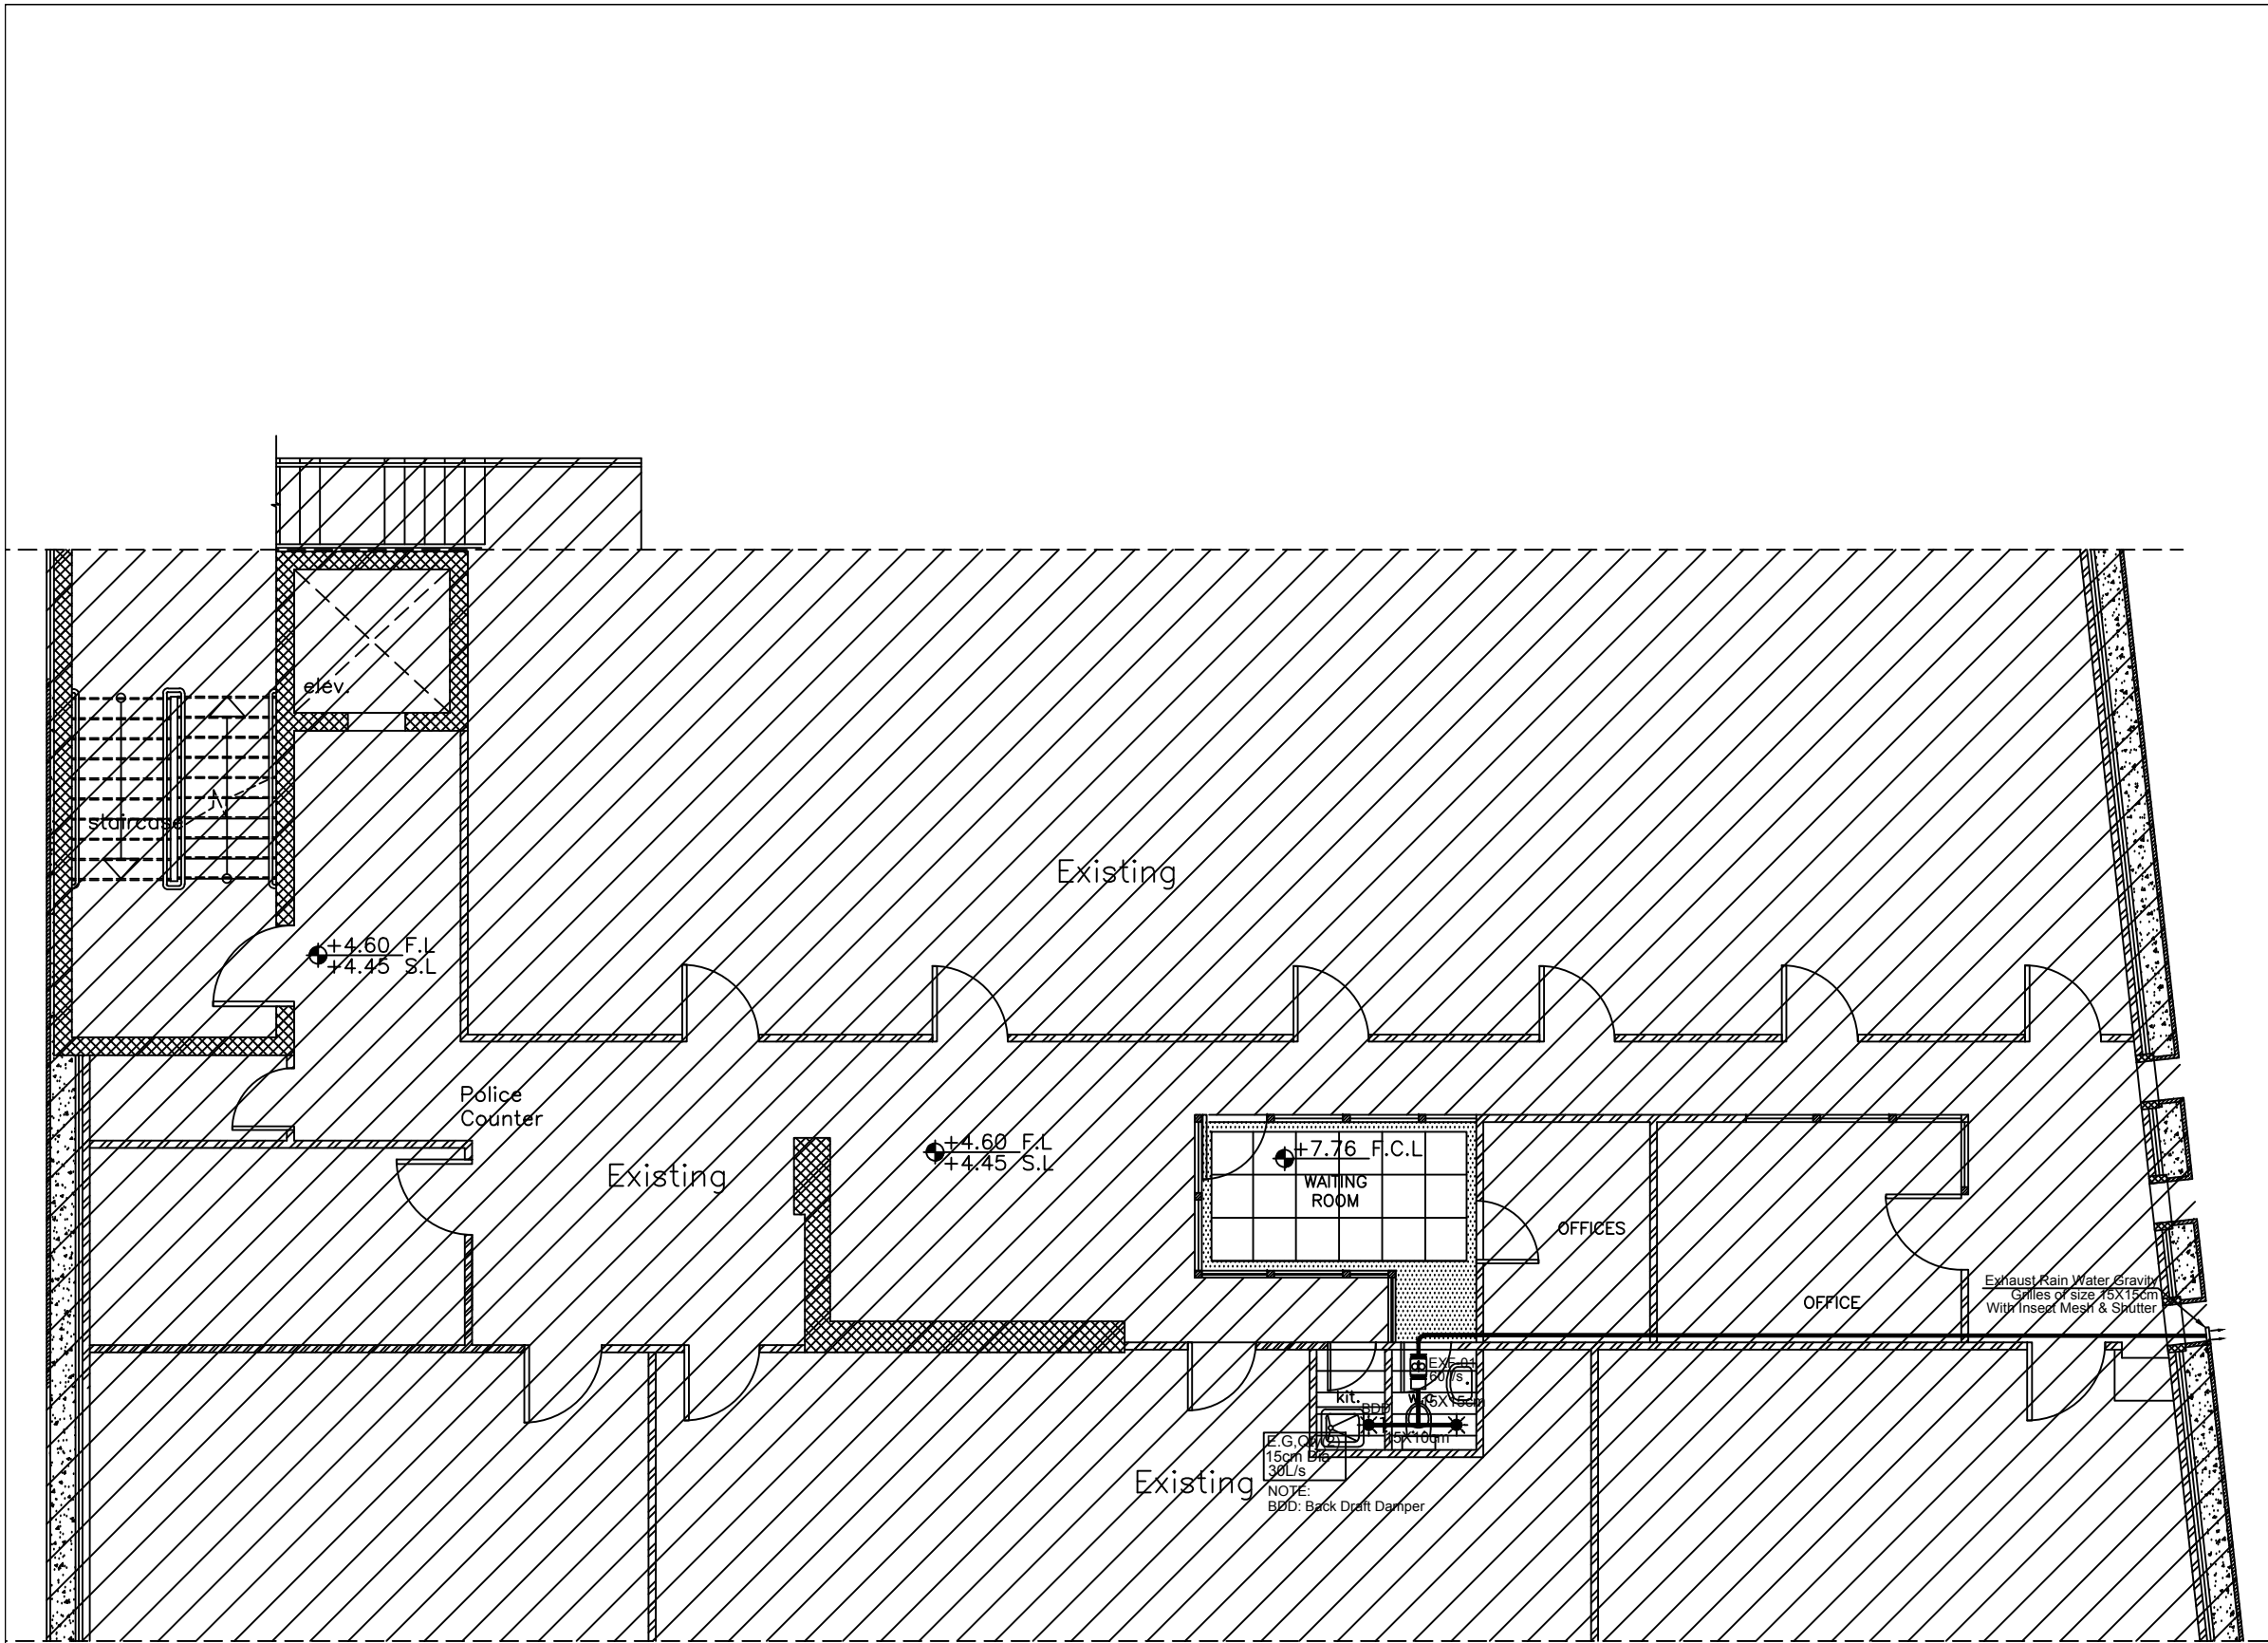

NOTES :

REVISION	DATE OF REVISION	INITIALS	REVISION DETAILS



ESTABLISH A SPECIALIZED COURT
IN NABLUS

PROJECT No. :

ISSUE : TENDER


First Floor
DRAWING : Ventilation System Layout

	DRAWN : DIAMOND STAFF	APPROVED: DIAMOND STAFF	DATE: JUNE, 2021
	NO :	NO. :	
	CHECKED: DIAMOND STAFF	REF:	SCALE: 1/100
	NO :		

SAFFARINI & ASSOCIATES
Ramallah
Fax 02-2959363
Tel 02-2987675

M502

Rev.: 2

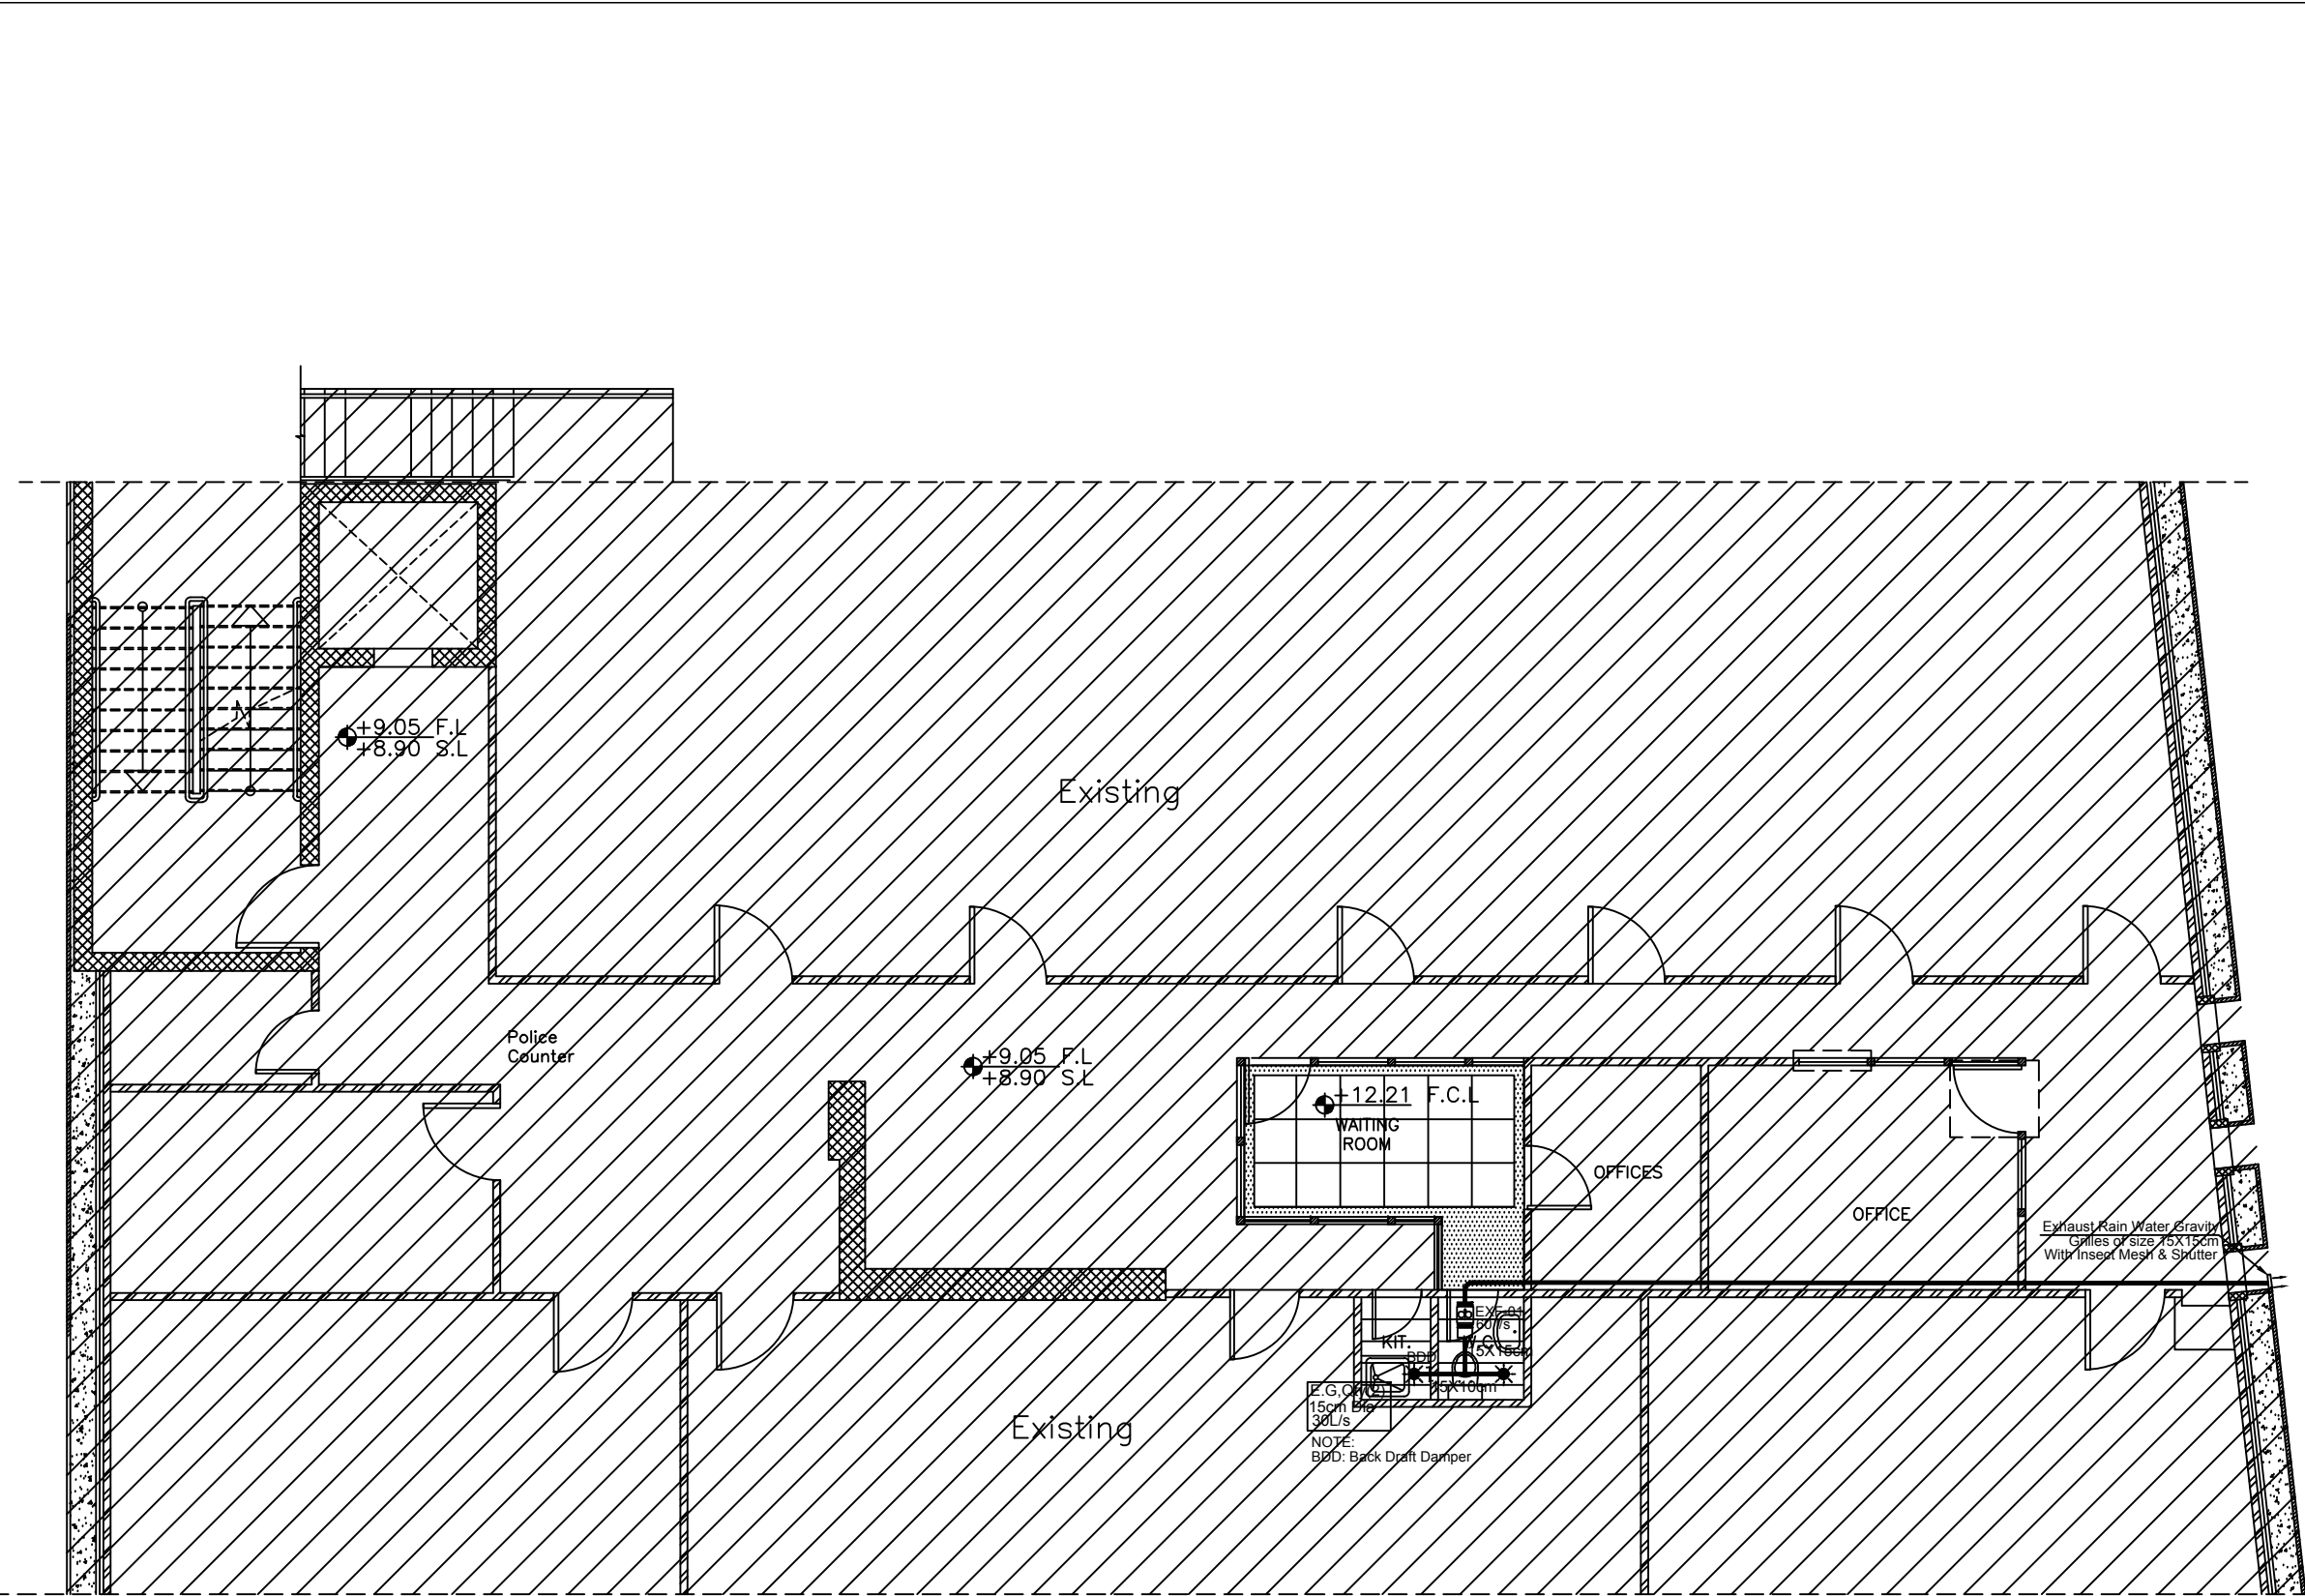

NOTES :

REVISION	DATE OF REVISION	INITIALS	REVISION DETAILS



ESTABLISH A SPECIALIZED COURT
IN NABLUS

PROJECT No. :

ISSUE : TENDER

Second Floor
DRAWING : Ventilation System Layout

DRAWN : DIAMOND STAFF NO. :	APPROVED: DIAMOND STAFF NO. :	DATE: JUNE, 2021			
			CHECKED: DIAMOND STAFF NO. :	REF:	SCALE: 1/100

SAFFARINI & ASSOCIATES
Ramallah
Fax 02-2959363
Tel 02-2987675

M503

Rev.: 2

DX Split Units Schedule														
REF.	DESIGNATION	QTY	NOMINAL AIR FLOW (L/S)	TOTAL COOLING CAPACITY (Kw)	SENSIBLE COOLING CAPACITY (Kw)	HEATING CAPACITY (Kw)	EXTERNAL STATIC PRESSURE (Pa)	ELECTRICAL DATA		ENTERING AIR TEMP.		LEAVING AIR TEMP.		REMARKS
								POWER (WATT)	V / Hz / Ø	DB °C	WB °C	DB °C	WB °C	
SP-1	DX Split Unit	4	180	3.5	3.0	2.6	----	1100	230/50/1	22.0	16.0	13.0	12.0	-----

DESIGN CONDITIONS:

- *INDOOR DESIGN TEMPERATURE = 22 C°
- *OUTDOOR SUMMER DESIGN TEMPERATURE = 38 C°
- *OUTDOOR WINTER DESIGN TEMPERATURE = 1.0 C
- *AIR FLOWS ABOVE ARE BASED ON MEDIUM FAN SPEED.

FANS SCHEDULE

FAN #	SERVED AREA	STATIC PRESSURE (WG INCH)	LOCATION	AIR FLOW (L/S)	MOTOR DATA					TYPE	QTY	ON DUTY	STAND -BY
					(RPM)	VOLTS	KW	Ø	HZ				
EXF-01	KITCHEN &TOILET/ 1ST &2ND FLOORS	0.25"	TOILET	60	1450	220	0.10	1	50	IN LINE TYPE	2	2	-
EXF-02	ARCHIVES / PARKING	0.25"	ARCHIVE	400	1450	220	0.30	1	50	CABINET ACOUSTIC	1	1	-
FAF-01	ARCHIVES / PARKING	0.30"	ARCHIVE	400	1450	220	0.30	1	50	CABINET ACOUSTIC	1	1	-







NOTES :

REVISION	DATE OF REVISION	INITIALS	REVISION DETAILS



ESTABLISH A SPECIALIZED COURT
IN NABLUS

PROJECT No. :			
ISSUE : TENDER			
DRAWING : Mechanical Schedules			
	DRAWN : DIAMOND STAFF NO :	APPROVED: DIAMOND STAFF NO. :	DATE: JUNE, 2021
	CHECKED: DIAMOND STAFF NO :	REF:	SCALE: N.T.S.
SAFFARINI & ASSOCIATES Ramallah Fax 02-2959363 Tel 02-2987675			M601 Rev.: 2

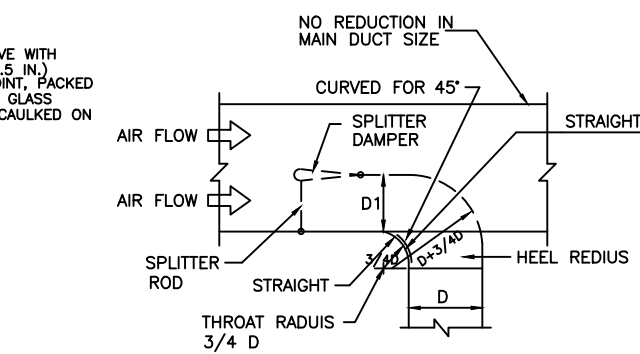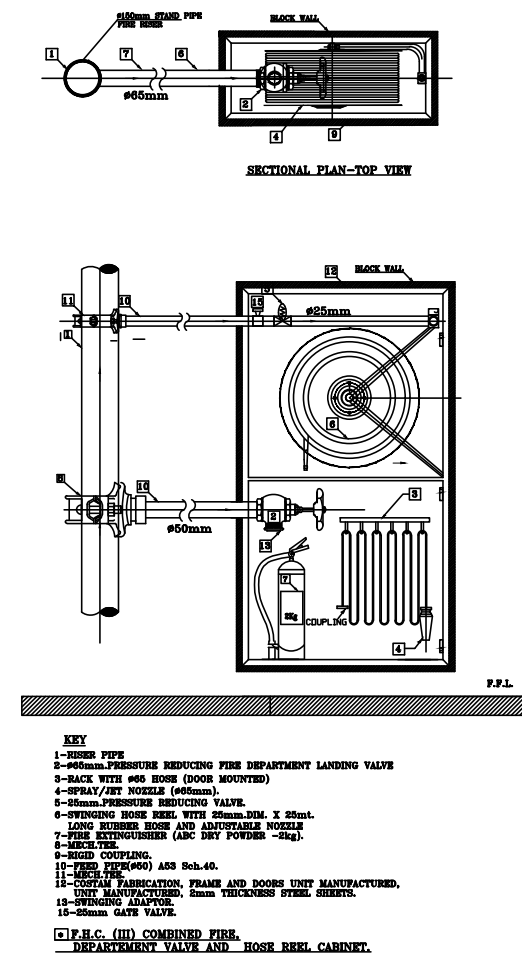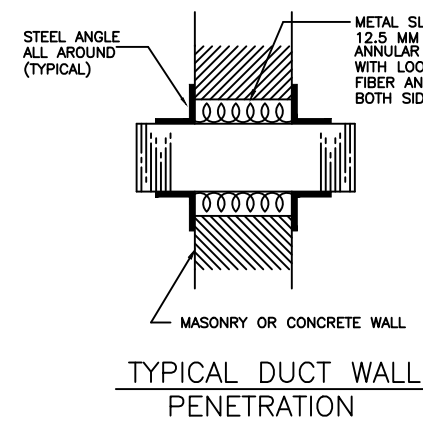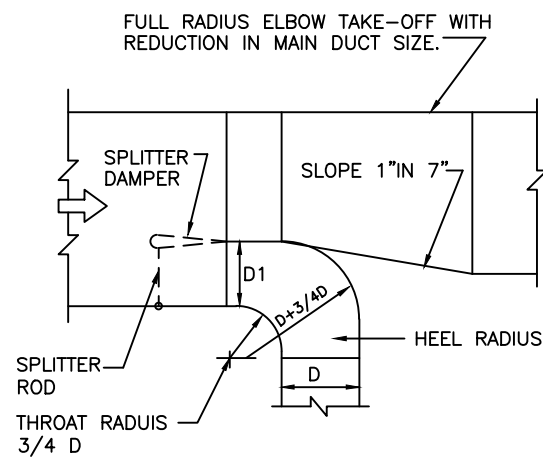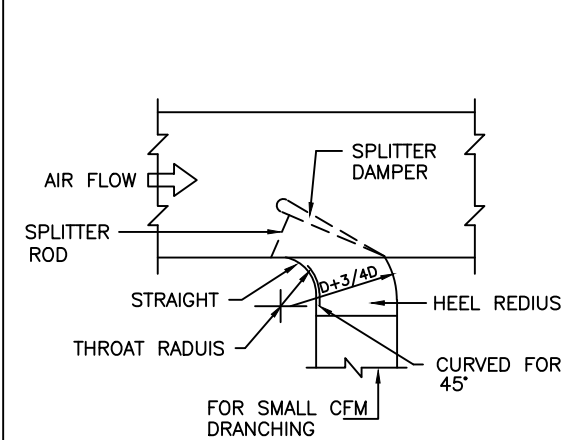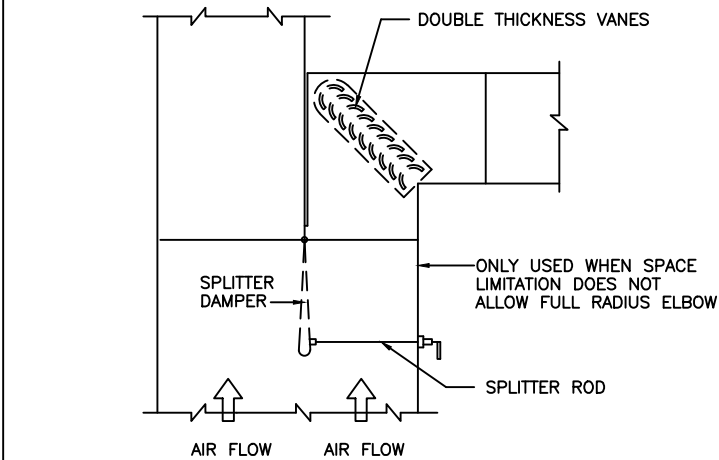

Technical drawing showing the side view of a fire extinguisher mounted on a wall. The extinguisher is represented by a vertical cylinder with a handle and nozzle assembly at the top. The mounting hardware is indicated by lines and text labels on the right side of the drawing:

- Screw $\varnothing 5\text{mm}$ L=50 mm**: Points to the top mounting screw.
- Hanger**: Points to the top mounting bracket.
- Fire Extinguisher**: Points to the main body of the extinguisher.
- Screw $\varnothing 5\text{mm}$ L=50 mm**: Points to the bottom mounting screw.
- Clip ring**: Points to the bottom mounting bracket.

Side Elevation

Front Elevation

CABINET HOSE REEL DETAL

REVISION	DATE OF REVISION	INITIALS	REVISION DETAILS
----------	------------------	----------	------------------



ESTABLISH A SPECIALIZED COURT IN NABLUS

PROJECT No. :

ISSUE : TENDER



DRAWING : Mechanical Details

	DRAWN : DIAMOND STAFF NO :	APPROVED: DIAMOND STAFF NO. :	DATE: JUNE, 2021
	CHECKED: DIAMOND STAFF NO :	REF:	SCALE: N.T.S.

SAFFARINI & ASSOCIATES
Ramallah
Fax 02-2959363
Tel 02-2987675

M701

  Rev.: 2

Materials	Symbols
2" HDPE	
4" HDPE	
4"Floor Trape	
Hot Water Pipe	
Cold Water pipe	
Water Collector	
Water Riser	
Water Electric Heater	
Exhaust Grille	
In-Line Ventilation Fan	
Ducted Volume Damper	
Indoor Wall Mounted Split Unit	
Outdoor Wall Mounted Split Unit	

Drawing Number	Description
M000	Mechanical Symbols & Legend
M101	Parking Floor Sanitary System Layout Plan
M102	First Floor Sanitary System Layout Plan
M103	Second Floor Sanitary System Layout Plan
M201	First Floor Water System Layout Plan
M202	Second Floor Water System Layout Plan
M301	Parking Floor Firefighting System Layout Plan
M302	Ground Floor Firefighting System Layout Plan
M303	First Floor Firefighting System Layout Plan
M304	Second Floor Firefighting System Layout Plan
M401	First Floor Air Conditioning System Layout Plan
M402	Second Floor Air Conditioning System Layout Plan
M501	Parking Floor Ventilation System Layout Plan
M502	First Floor Ventilation System Layout Plan
M503	Second Floor Ventilation System Layout Plan
M601	Mechanical Schedules
M701	Mechanical Details

NOTES :

REVISION	DATE OF REVISION	INITIALS	REVISION DETAILS



ESTABLISH A SPECIALIZED COURT
IN NABLUS

PROJECT No. :

ISSUE : TENDER

DRAWING : Mechanical Symbols & Legend

	DRAWN : DIAMOND STAFF	APPROVED: DIAMOND STAFF	DATE: JUNE, 2021
	NO :	NO. :	
	CHECKED: DIAMOND STAFF	REF:	SCALE: N.T.S.
	NO :		

SAFFARINI & ASSOCIATES
Ramallah
Fax 02-2959363
Tel 02-2987675

M000

Rev.: 2