


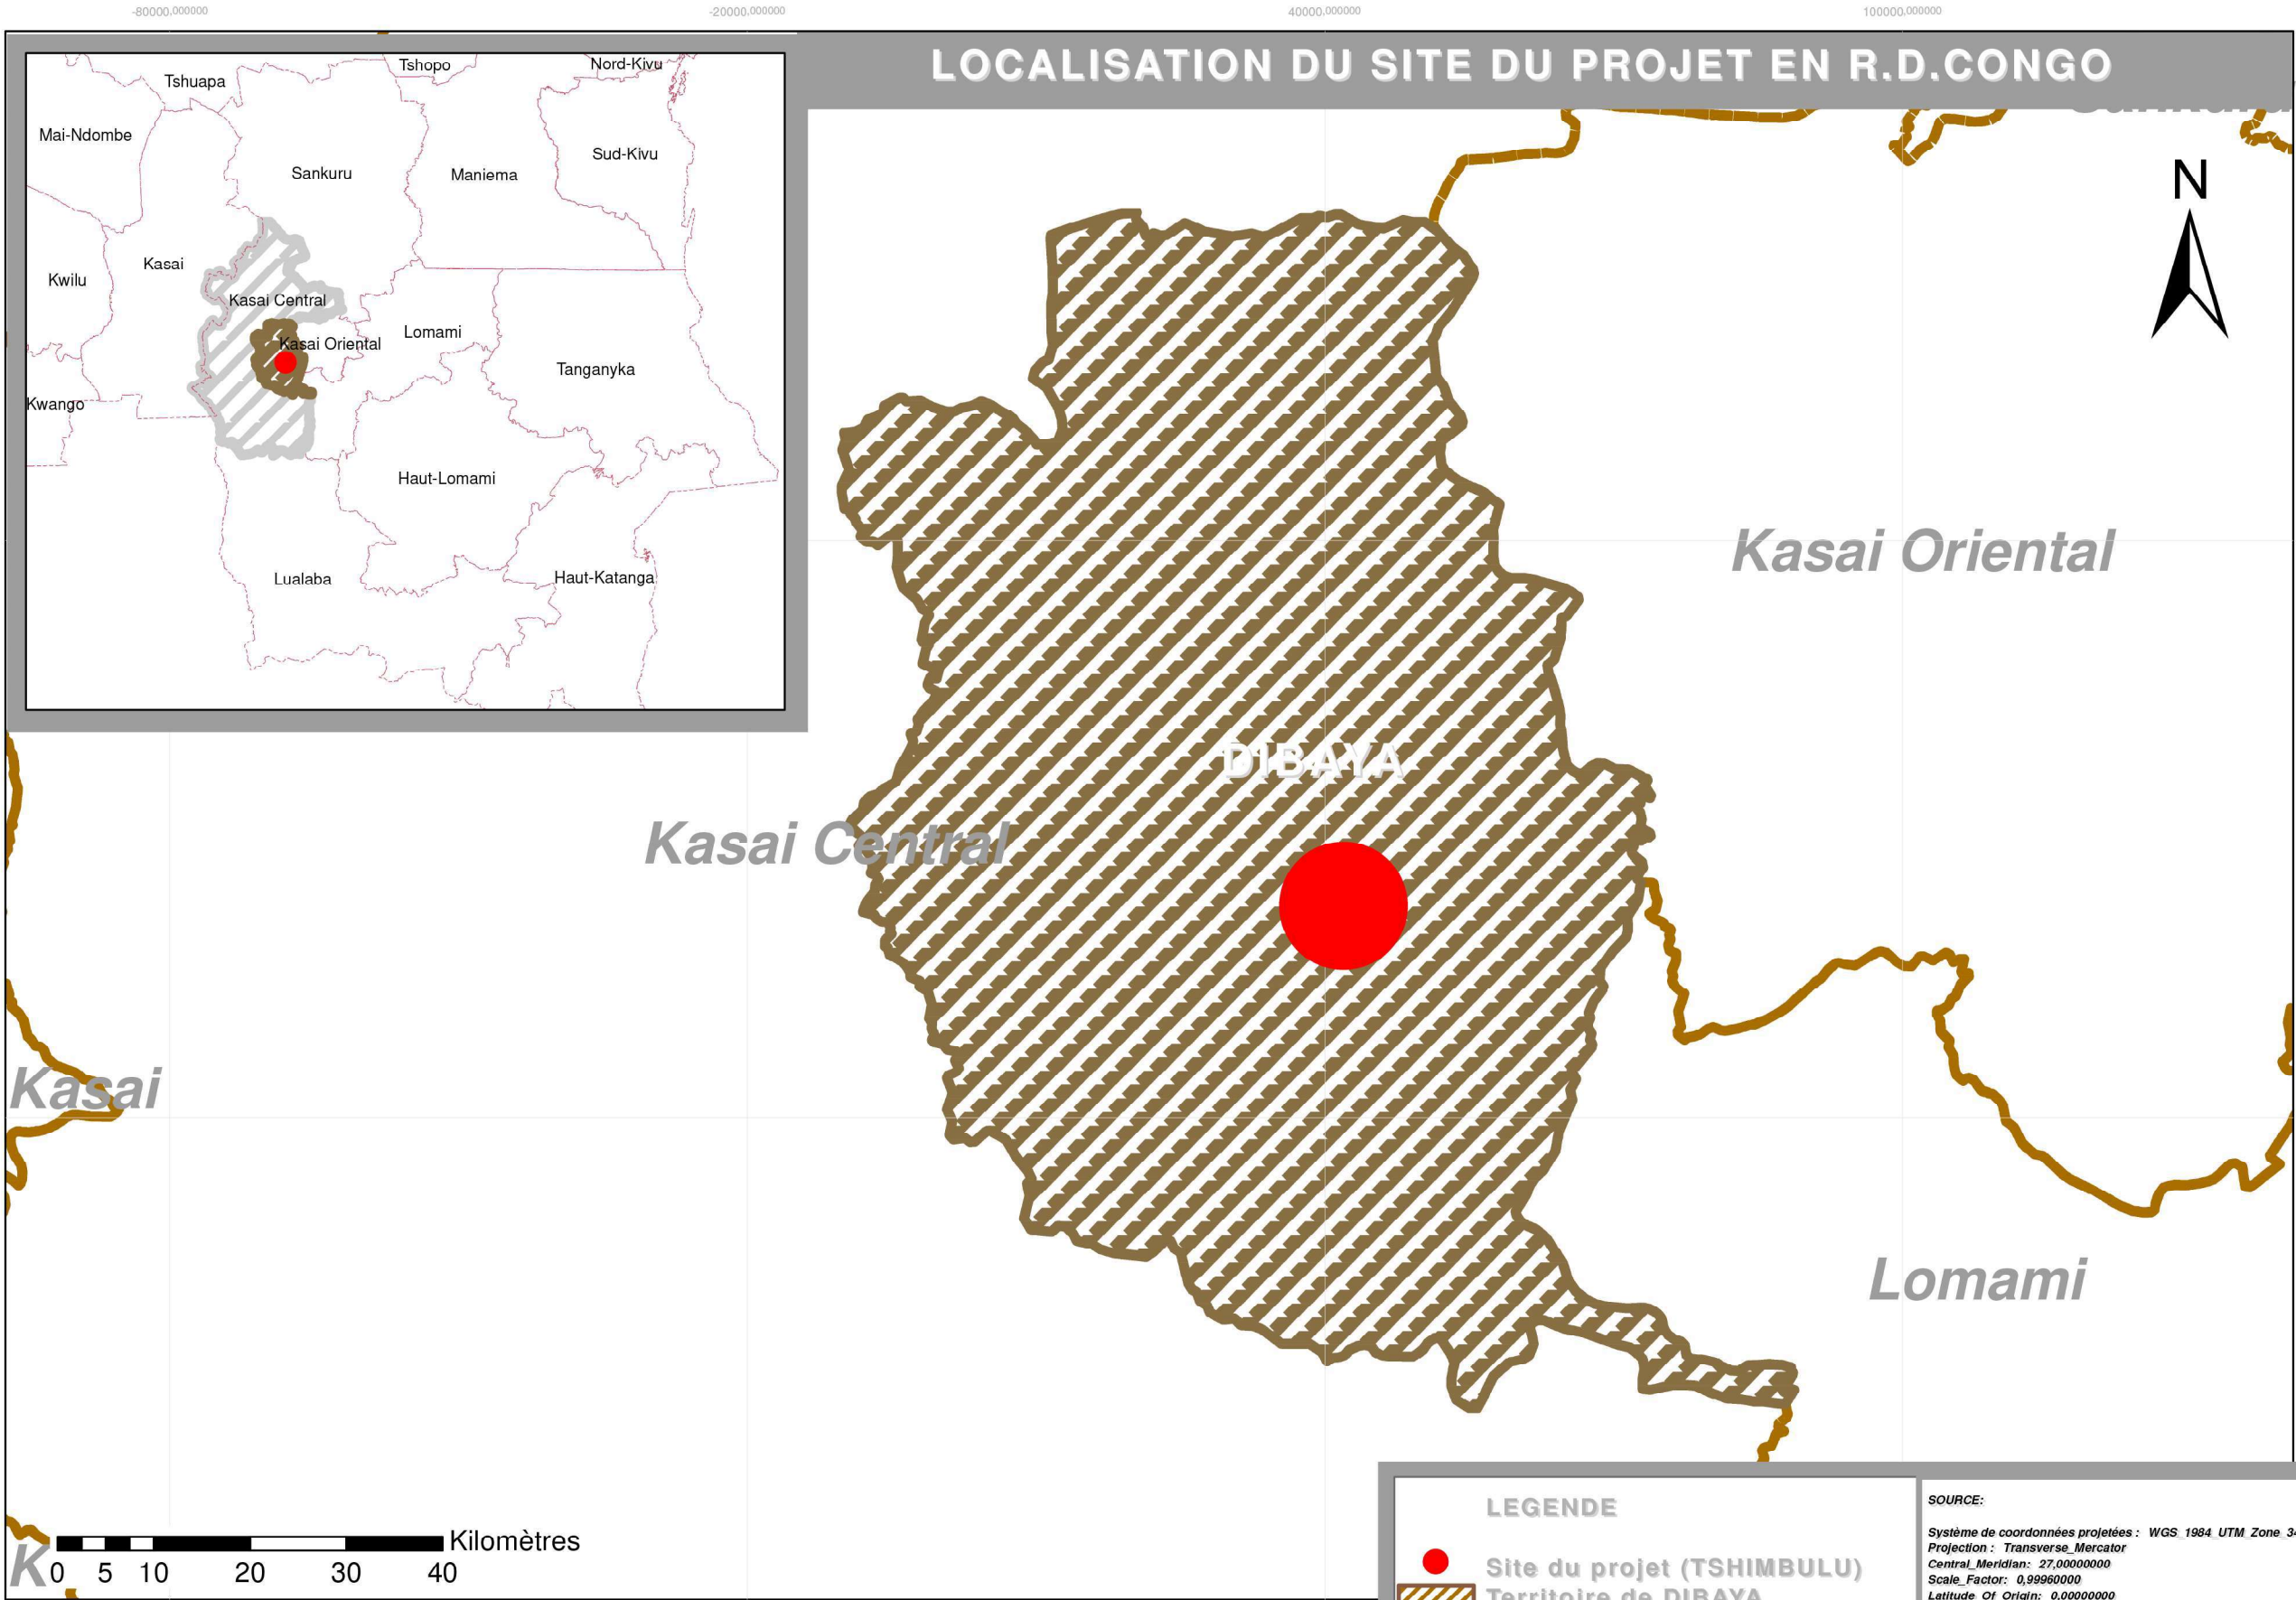

SITE KEY PLAN

REVISION RECORD

	Date Drawn	DESCRIPTION		
No2	22/06/21			
DRAWN BY		REGISTRATION NO	DATE	SIGNATURE
CHECKED BY		REGISTRATION NO	DATE	SIGNATURE
APPROVED BY		REGISTRATION NO	DATE	SIGNATURE

CLIENT:

IMPLEMENTING AGENT:



DRAWING DESCRIPTION

PARQUET DE GRANDE INSTANCE DE
TSHIMBULU
R.D.CONGO

PLAN DE LOCALISATION

ECHELLE:		BOARD NUMBER: 01	
DATE	OCTOBER 2021	SCALE	AS SHOWN
DRW NO.	PAL/BT/2021/201	DRAWN	M.A.K
			SIZE A3



SITE KEY PLAN

REVISION RECORD

No2	Date Drawn	DESCRIPTION			
		REGISTRATION NO	DATE	SIGNATURE	
22/06/21					

CLIENT:

IMPLEMENTING AGENT:



Empowered lives.
Resilient nations.

DRAWING DESCRIPTION

PARQUET DE GRANDE INSTANCE DE
TSHIMBULU
R.D.CONGO


PLAN DE SITUATION

Echelle: 1/500		BOARD NUMBER: 02	
DATE	OCTOBER 2021	SCALE	AS SHOWN
DRW NO.	PAL/BT/2021/201	SIZE	A3

LEGENDE

- 1 AVENUE PRINCIPALE
- 2 ENTREE PRINCIPALE
- 3 BATIMENT (TRIPAIX)
- 4 PATIO
- 5 TOILETTE
- 6 CIRCULATION
- 7 VEGETATION

- 1 AVENUE PRINCIPALE
- 2 ENTREE PRINCIPALE
- 3 BATIMENT (TRIPAIX)
- 4 PATIO
- 5 TOILETTE
- 6 CIRCULATION
- 7 VEGETATION

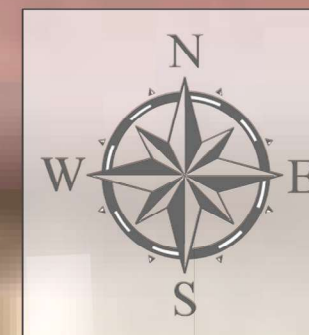

SITE KEY PLAN

REVISION	RECORD

No2	Date Drawn	DESCRIPTION		
	22/08/21			

DRAWN BY		REGISTRATION NO	DATE	SIGNATURE
CHECKED BY		REGISTRATION NO	DATE	SIGNATURE
APPROVED BY		REGISTRATION NO	DATE	SIGNATURE

CLIENT:

IMPLEMENTING AGENT:



	DRAWING DESCRIPTION
--	---------------------

PARQUET DE GRANDE INSTANCE DE
TSHIMBULU
R.D.CONGO



PLAN D'ENSEMBLE

ECHELLE: 1/200

BOARD NUMBER: 04

DATE	OCTOBER 2021	SCALE	AS SHOWN	DRAWN	M A K
DRW NO.	PAL/BT/2021/201				SIZE

- 1 AVENUE PRINCIPALE
- 2 ENTREE PRINCIPALE
- 3 BATIMENT (TRIPAIX)
- 4 PATIO
- 5 TOILETTE
- 6 CIRCULATION
- 7 VEGETATION

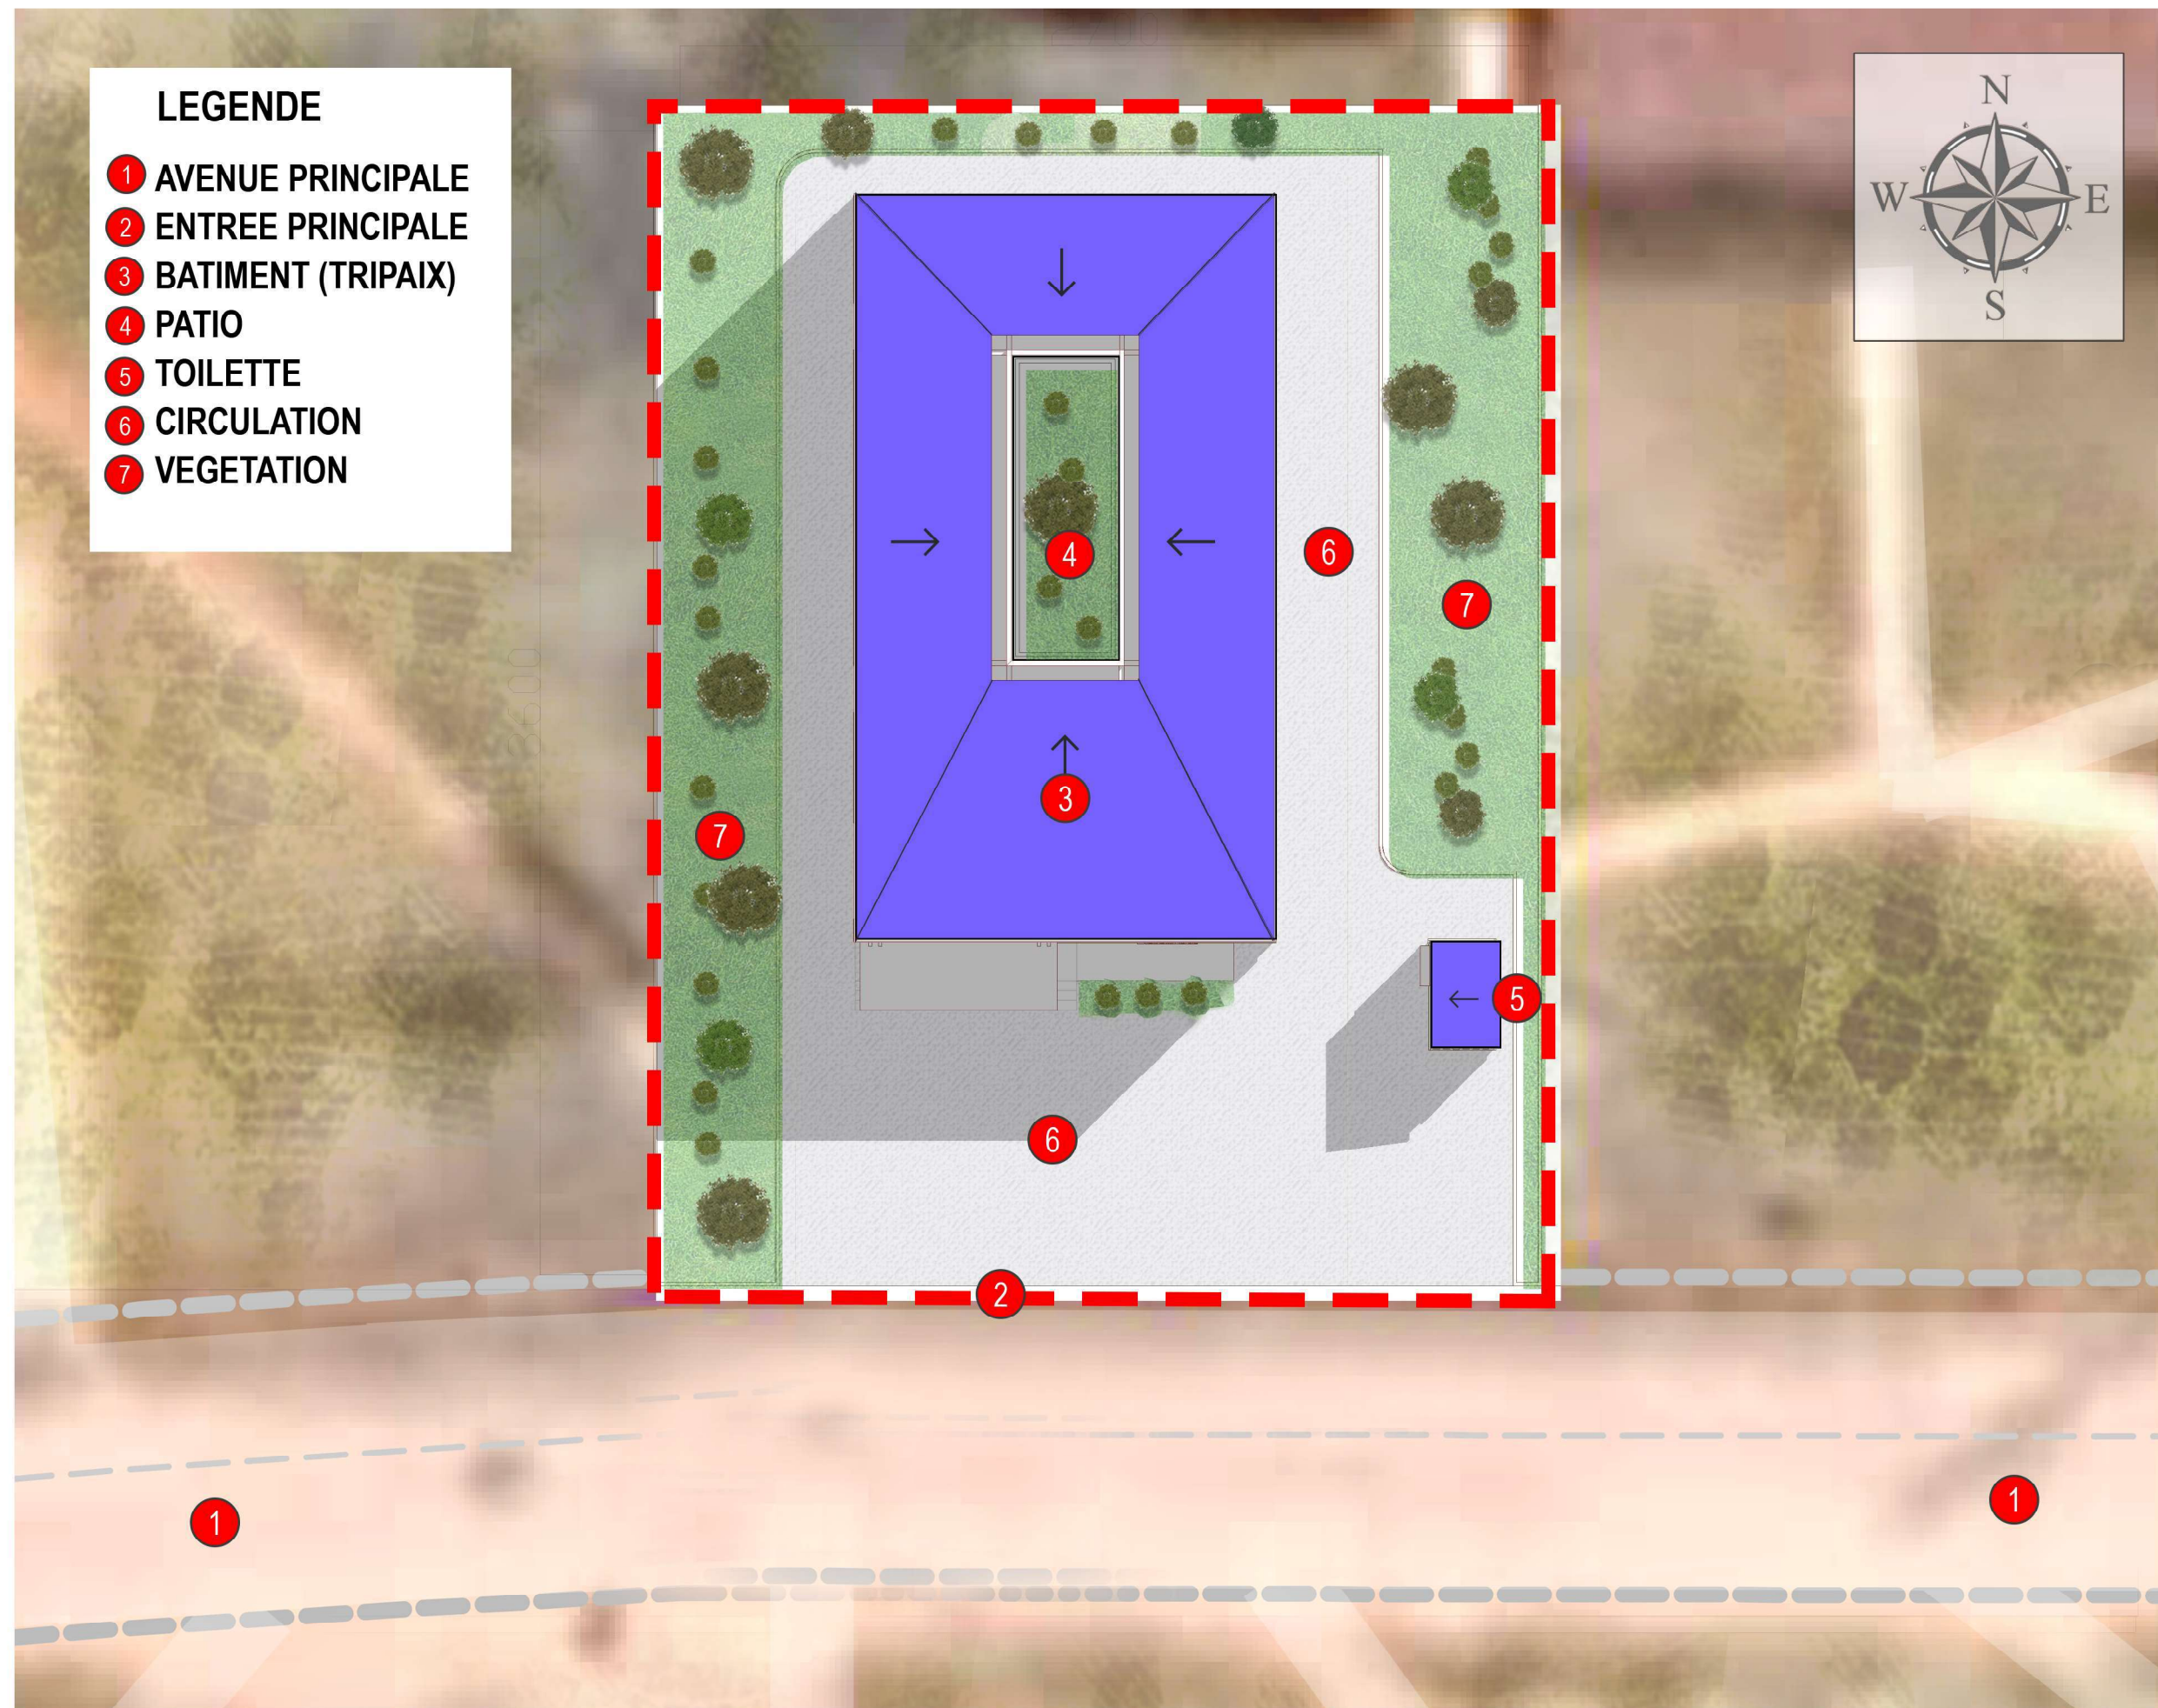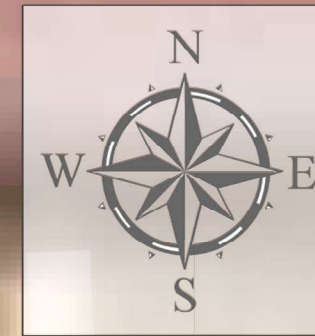


SITE KEY PLAN

REVISION	RECORD
----------	--------

	Date Drawn	DESCRIPTION		
No2	22/06/21			
	--			
DRAWN BY		REGISTRATION NO	DATE	SIGNATURE
CHECKED BY		REGISTRATION NO	DATE	SIGNATURE
APPROVED BY		REGISTRATION NO	DATE	SIGNATURE

CLIENT:

IMPLEMENTING AGENT:

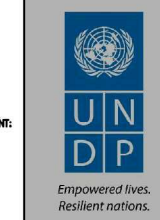

DRAWING DESCRIPTION	
---------------------	--


PARQUET DE GRANDE INSTANCE DE
TSHIMBULU
R.D.CONGO

PLAN DE MASSE

ECHELLE: 1/200

BOARD NUMBER: 05

DATE	OCTOBER 2021	SCALE	AS SHOWN	DRAWN	M A K
DRW NO.	PAL/BT/2021/201				SIZE A3

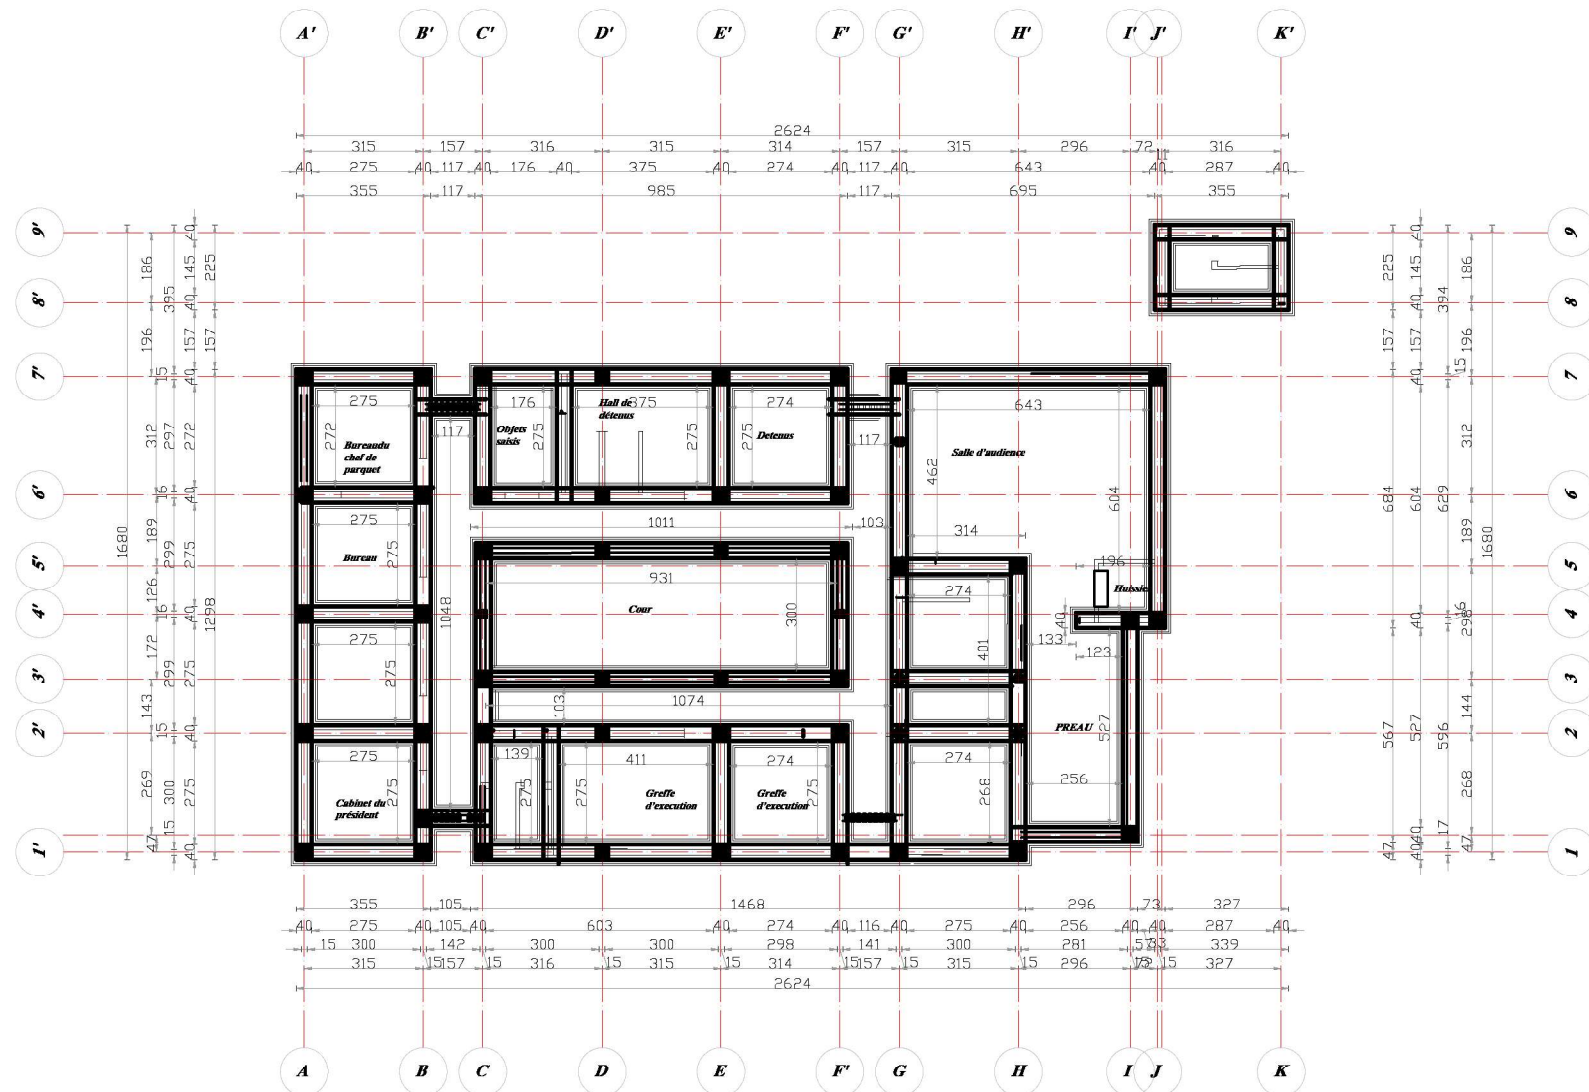

SITE KEY PLAN

REVISION RECORD

No2	Date Drawn	DESCRIPTION		

		DRAWN BY	REGISTRATION NO	DATE SIGNATURE
		CHECKED BY	REGISTRATION NO	DATE SIGNATURE
		APPROVED BY	REGISTRATION NO	DATE SIGNATURE

CLIENT:

IMPLEMENTING AGENCY:




Empowered lives.
Resilient nations.

DRAWING DESCRIPTION

PARQUET DE GRANDE INSTANCE DE
TSHIMBULU
R.D.CONGO

VUE EN PLAN DE FONDATION

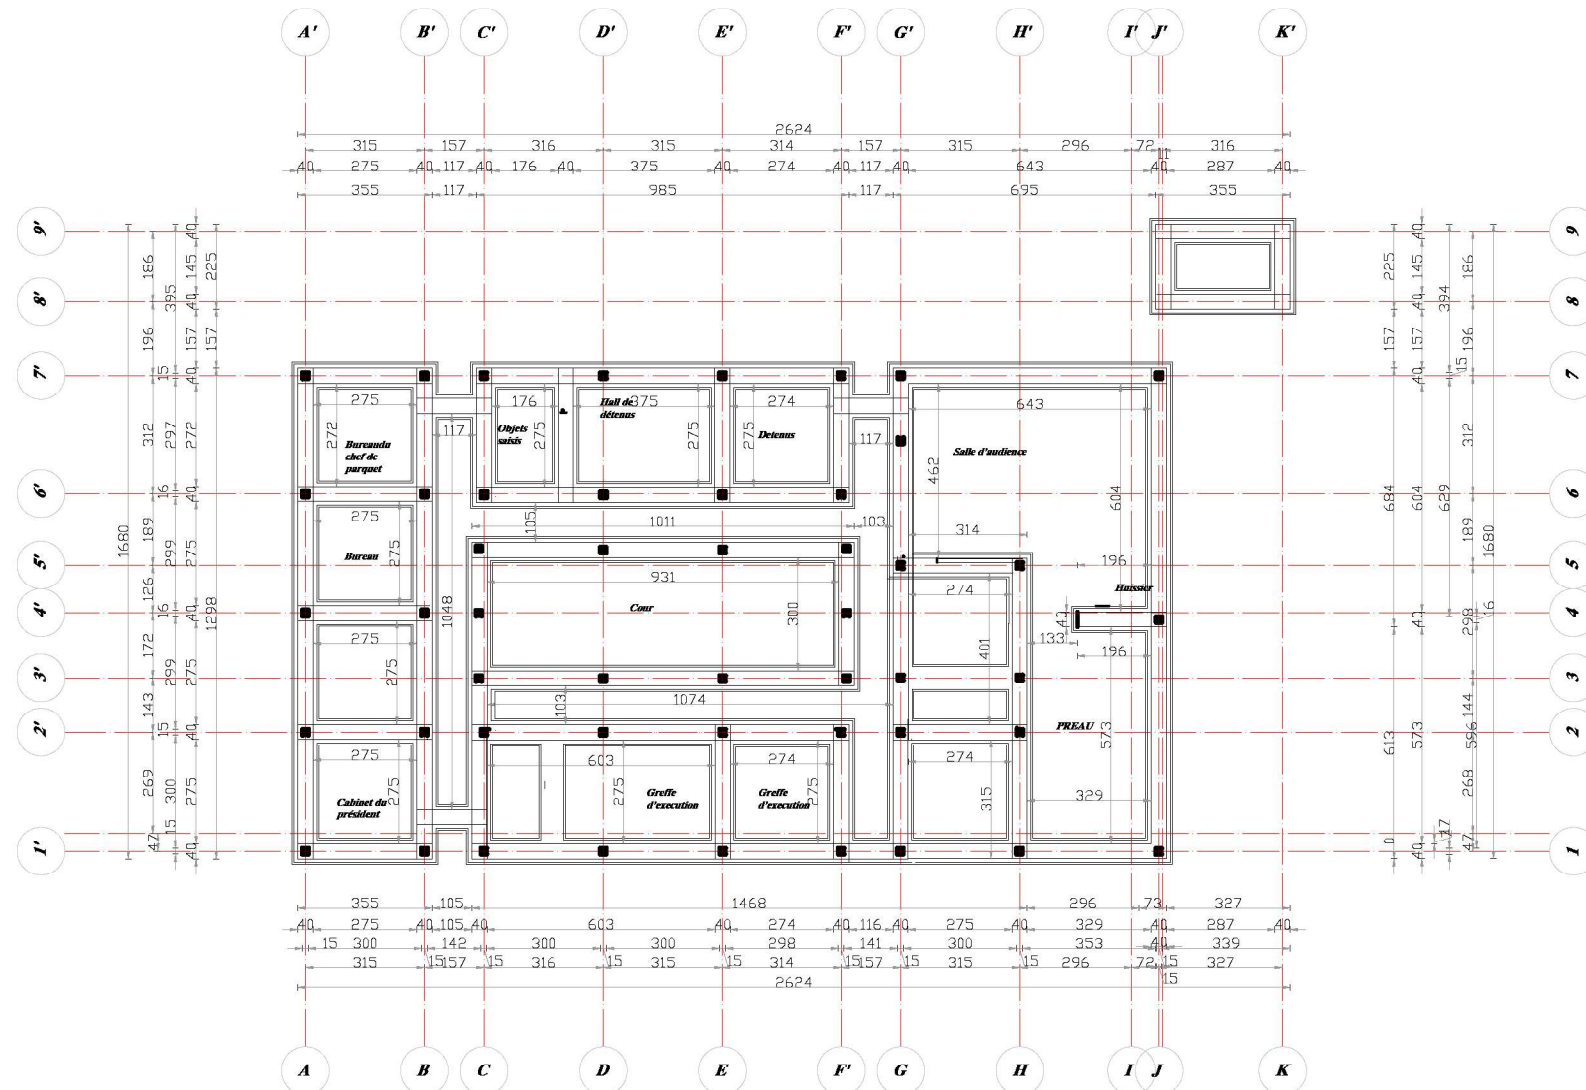

SITE KEY PLAN

REVISION RECORD

No2	Date Drawn	DESCRIPTION			

DRAWN BY	REGISTRATION NO	DATE	SIGNATURE		
CHECKED BY	REGISTRATION NO	DATE	SIGNATURE		
APPROVED BY	REGISTRATION NO	DATE	SIGNATURE		

CLIENT:

IMPLEMENTING AGENCY:



DRAWING DESCRIPTION

PARQUET DE GRANDE INSTANCE DE
TSHIMBULU
R.D.CONGO

VUE EN PLAN DE STRUCTURE

ECHELLE: 1/200

BOARD NUMBER: 07

DATE	SCALE	DRAWN	M.A.K.
OCTOBER 2021	AS SHOWN		
DRW NO. PAL/BT/2021/201			SIZE A3




CLIENT:			
IMPLEMENTING AGENCY:	  <i>Empowered lives. Resilient nations.</i>		

DRAWING DESCRIPTION

PARQUET DE GRANDE INSTANCE DE
TSHIMBULU
R.D.CONGO

VUE EN PLAN COTEE

Echelle: 1/200		Board Number: 08	
Date: OCTOBER 2021	Scale: AS SHOWN	Drawn: M.A.K	
DWG NO. PAL/BT/2021/201			Size: A3

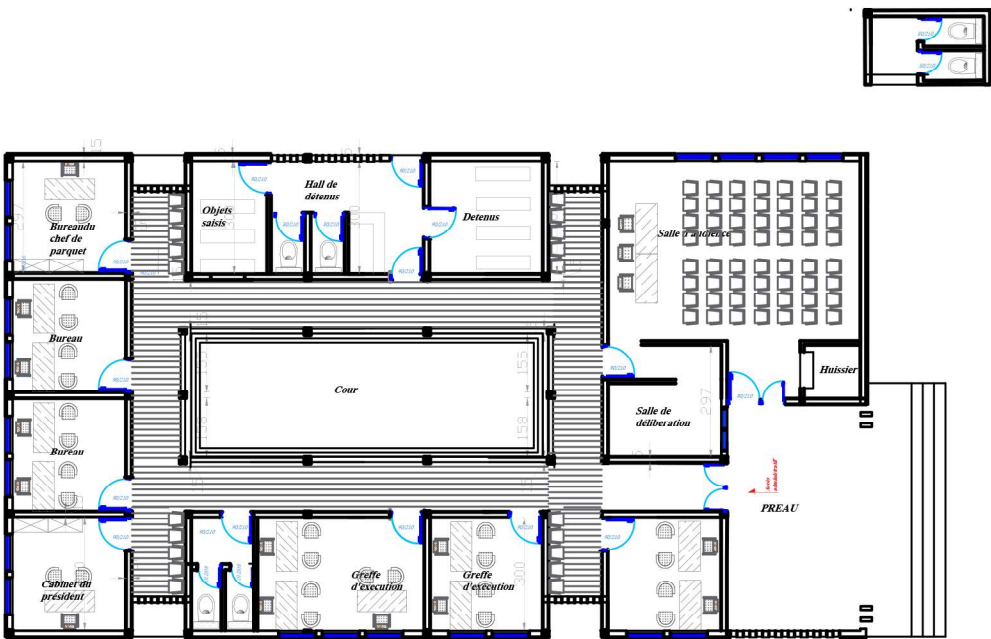

SITE KEY PLAN

REVISION RECORD

No2	Date Drawn	DESCRIPTION		
		REGISTRATION NO	DATE	SIGNATURE
22/06/21				

CLIENT:

IMPLEMENTING AGENT:




DRAWING DESCRIPTION

PARQUET DE GRANDE INSTANCE DE
TSHIMBULU
R.D.CONGO

VUE EN PLAN AMENAGEE

ECHELLE: 1/200		BOARD NUMBER: 09	
DATE	OCTOBER 2021	SCALE	AS SHOWN
DRW NO.	PAL/BT/2021/201	DRAWN	M A K
		SIZE	A3

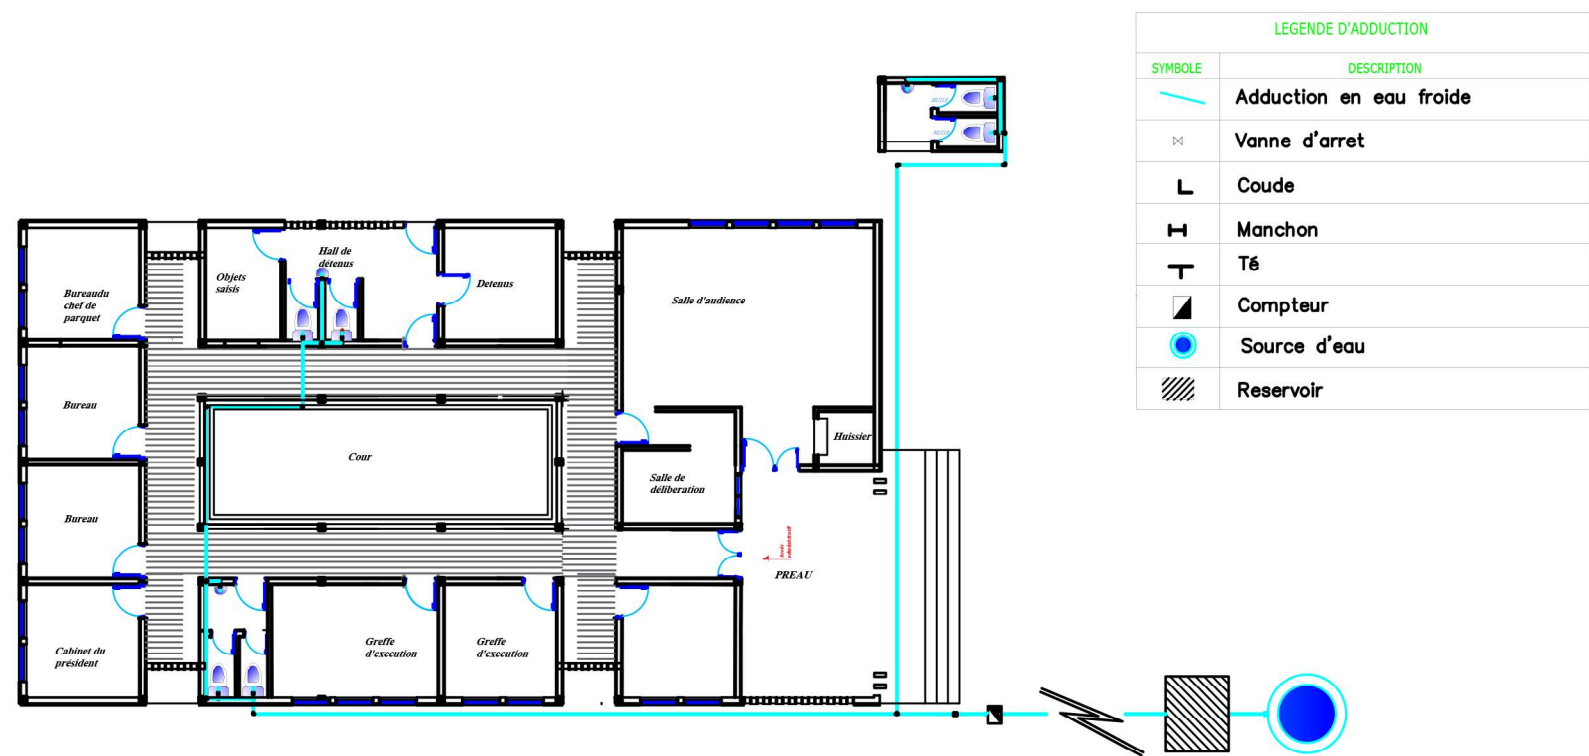


SITE KEY PLAN

REVISION RECORD

No2	Date Drawn	DESCRIPTION		
		REGISTRATION NO	DATE	SIGNATURE
22/06/21				

CLIENT:

IMPLEMENTING AGENT:

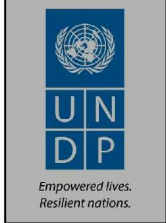


DRAWING DESCRIPTION

PARQUET DE GRANDE INSTANCE DE
TSHIMBULU
R.D.CONGO

VUE EN PLAN PLOMBERIE
ADDITION

Echelle: 1/200		BOARD NUMBER: 10	
DATE	OCTOBER 2021	SCALE	AS SHOWN
DRW NO.	PAL/BT/2021/201	DRAWN	M.A.K.
		SIZE	A3

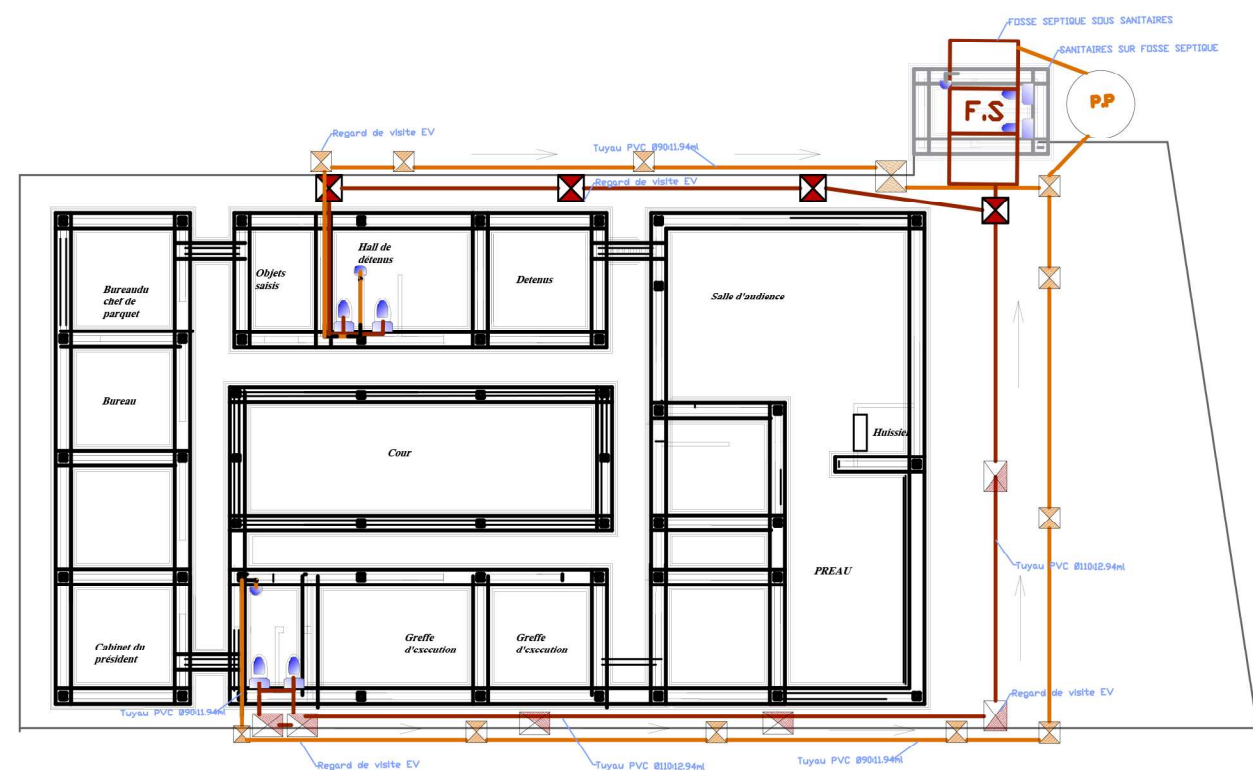

LEGENDE D'EVACUATION	
SYMBOLE	DESCRIPTION
	Evacuation des eaux usées
	Evacuation des eaux vannes
	Coude de 120
	Coude de 90
	Machon
	Té
	Bac de degasseur
	Regard de visite des eaux vannes
	Regard de visite
	Fosse septique
	puit perdant

SITE KEY PLAN

REVISION RECORD

No2	Date Drawn	DESCRIPTION			

		DRAWN BY	REGISTRATION NO	DATE	SIGNATURE
		CHECKED BY	REGISTRATION NO	DATE	SIGNATURE
		APPROVED BY	REGISTRATION NO	DATE	SIGNATURE

CLIENT:

IMPLEMENTING AGENT:

Empowered lives.
Resilient nations.

DRAWING DESCRIPTION

PARQUET DE GRANDE INSTANCE DE
TSHIMBULU
R.D.CONGO

VUE EN PLAN PLOMBERIE
EVUACUATION


ECHELLE: 1/200

BOARD NUMBER: 11

DATE	SCALE	DRAWN	M.A.K
OCTOBER 2021	AS SHOWN		

DRW NO. PAL/BT/2021/201

SIZE A3

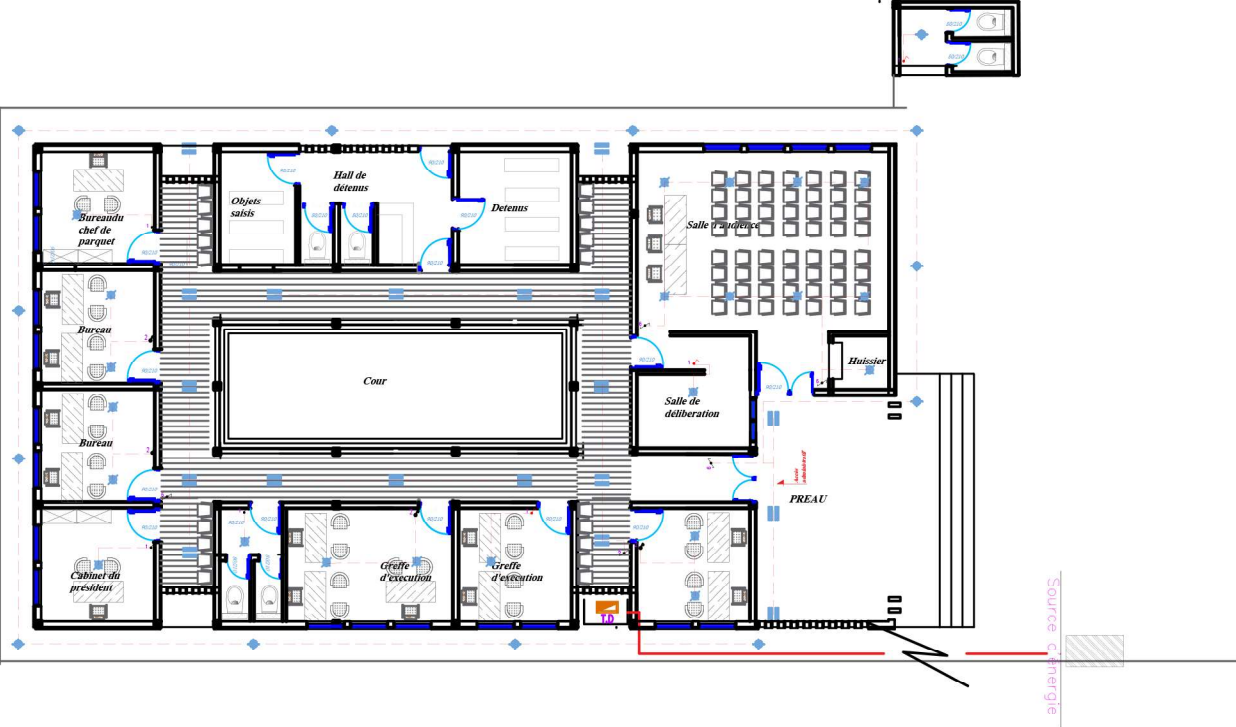

SITE KEY PLAN

REVISION RECORD

Date Drawn		DESCRIPTION			
No2	22/06/21				
DRAWN BY	REGISTRATION NO	DATE	SIGNATURE		
CHECKED BY	REGISTRATION NO	DATE	SIGNATURE		
APPROVED BY	REGISTRATION NO	DATE	SIGNATURE		

CLIENT:

IMPLEMENTING AGENT:




Empowered lives.
Resilient nations.

DRAWING DESCRIPTION

PARQUET DE GRANDE INSTANCE DE
TSHIMBULU
R.D.CONGO

VUE EN PLAN ELECTRICITE

Echelle: 1/200		BOARD NUMBER: 12	
DATE	OCTOBER 2021	SCALE	AS SHOWN
DRW NO.	PAL/BT/2021/201	DRAWN	M.A.K.
		SIZE	A3

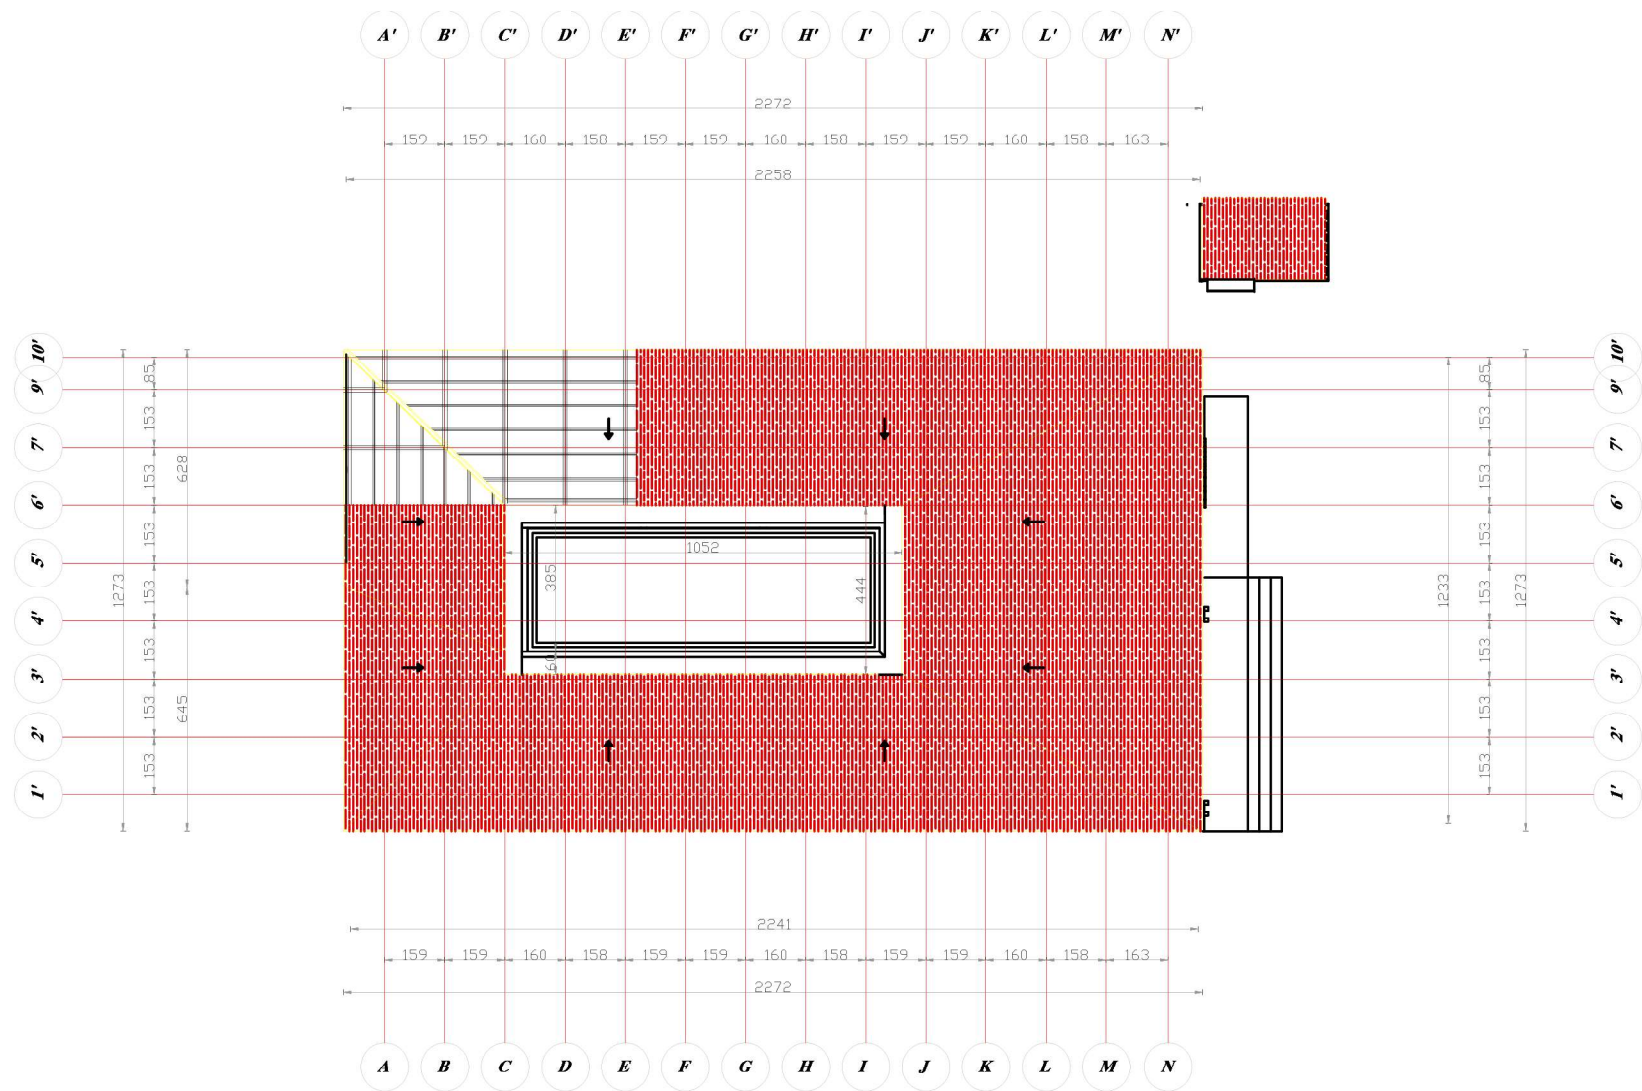

SITE KEY PLAN

REVISION RECORD

No2	Date Drawn	DESCRIPTION		
	22/08/21			
DRAWN BY	REGISTRATION NO	DATE	SIGNATURE	
CHECKED BY	REGISTRATION NO	DATE	SIGNATURE	
APPROVED BY	REGISTRATION NO	DATE	SIGNATURE	

CLIENT:

IMPLEMENTING AGENT:



DRAWING DESCRIPTION

PARQUET DE GRANDE INSTANCE DE
TSHIMBULU
R.D.CONGO

VUE EN PLAN DE TOITURE



ECHELLE: 1/200

BOARD NUMBER:

13

DATE	OCTOBER 2021	SCALE	AS SHOWN	DRAWN	M.A.K
DRW NO.	PAL/BT/2021/201	SIZE	A3		

COUPE B-B'

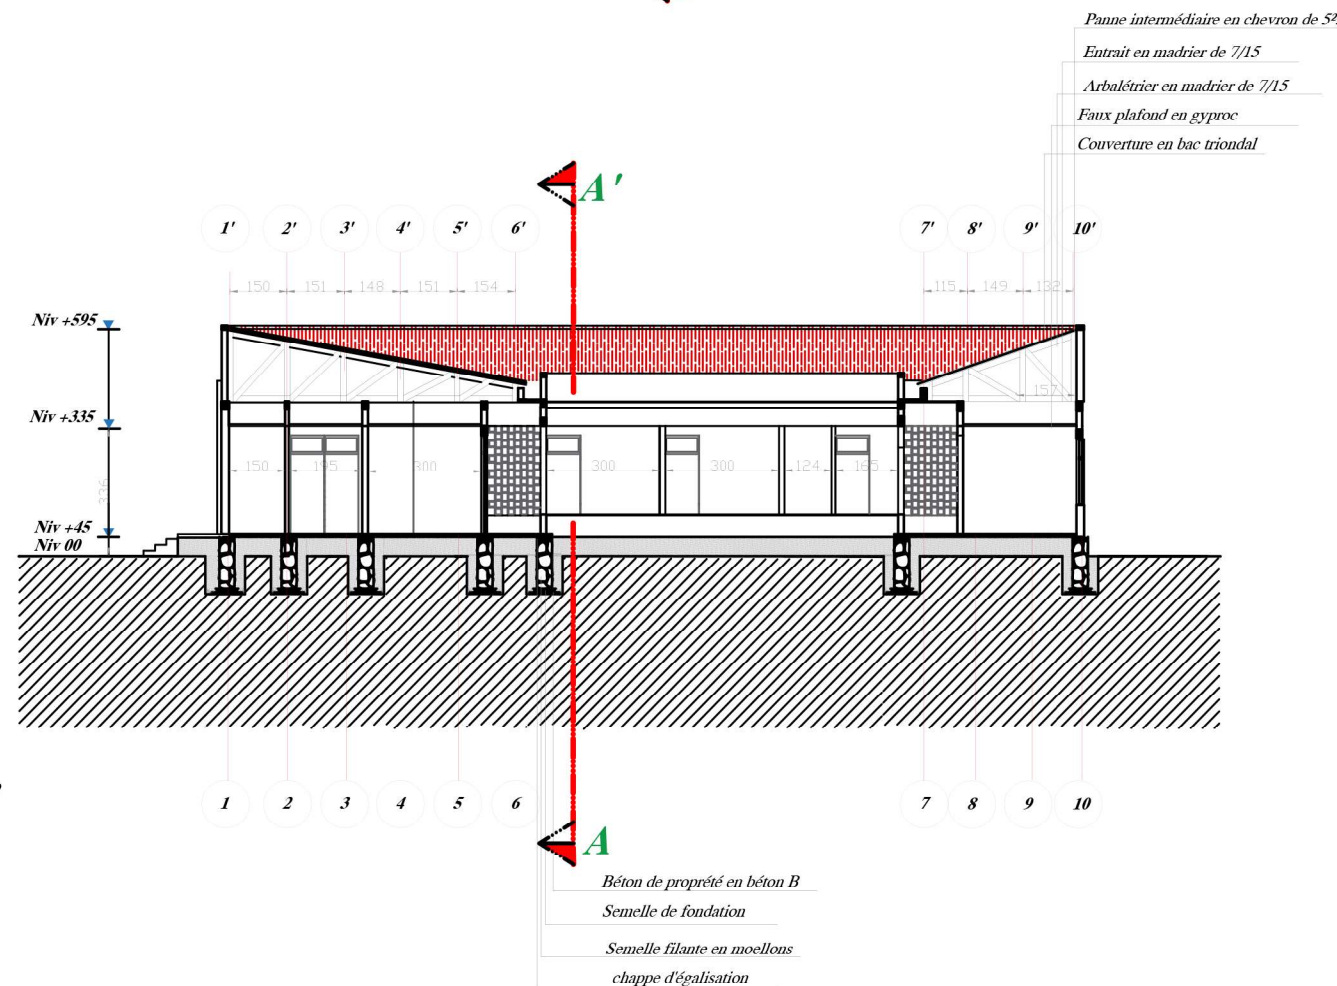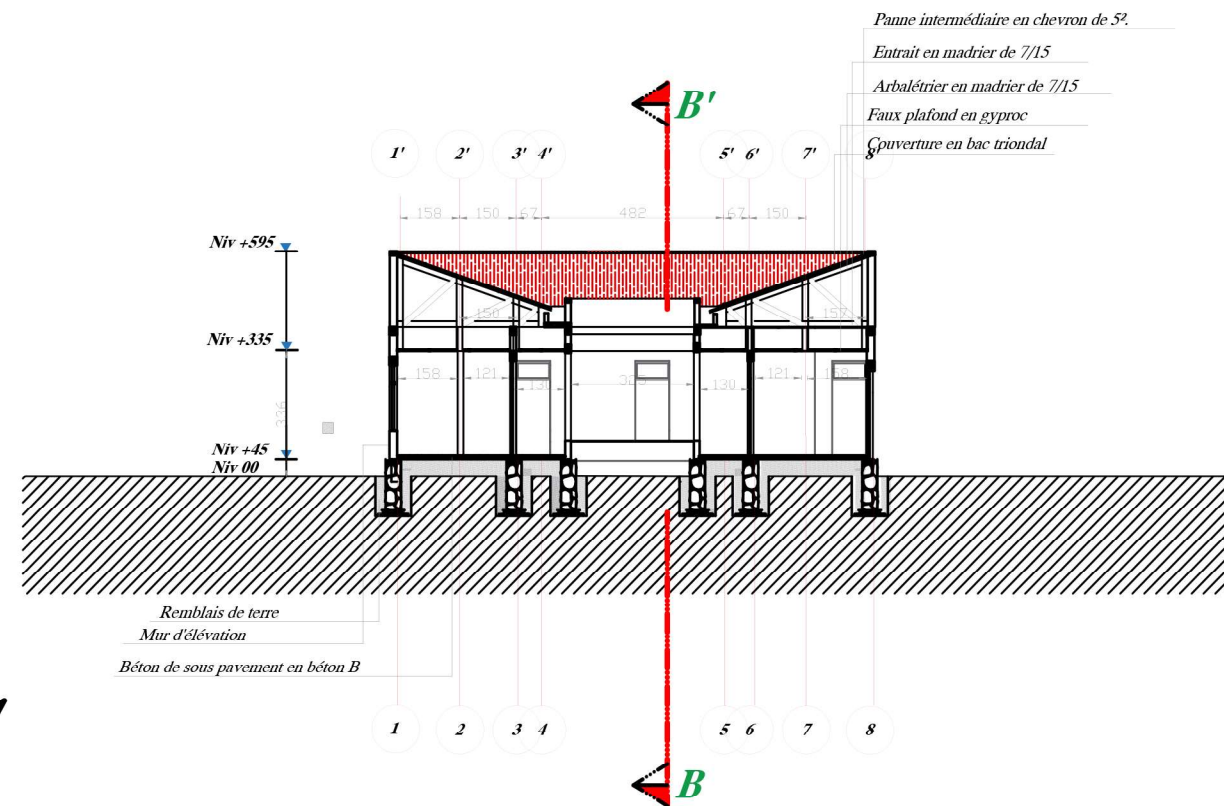

SITE KEY PLAN

REVISION RECORD				
	Date Drawn	DESCRIPTION		
No2	22/06/21 ---			
DRAWN BY		REGISTRATION NO	DATE	SIGNATURE
CHECKED BY		REGISTRATION NO	DATE	SIGNATURE
APPROVED BY		REGISTRATION NO	DATE	SIGNATURE

CLIENT:




IMPLEMENTING AGENT:


Empowered lives.
Resilient nations.

DRAWING DESCRIPTION
PARQUET DE GRANDE INSTANCE DE TSHIMBULU R.D.CONGO
COUPES

ECHELLE: 1/200		BOARD NUMBER: 14	
DATE	OCTOBER 2021	SCALE	AS SHOWN
DRAWN		M A K	
DRW NO. PAL/BT/2021/201			SIZE A3

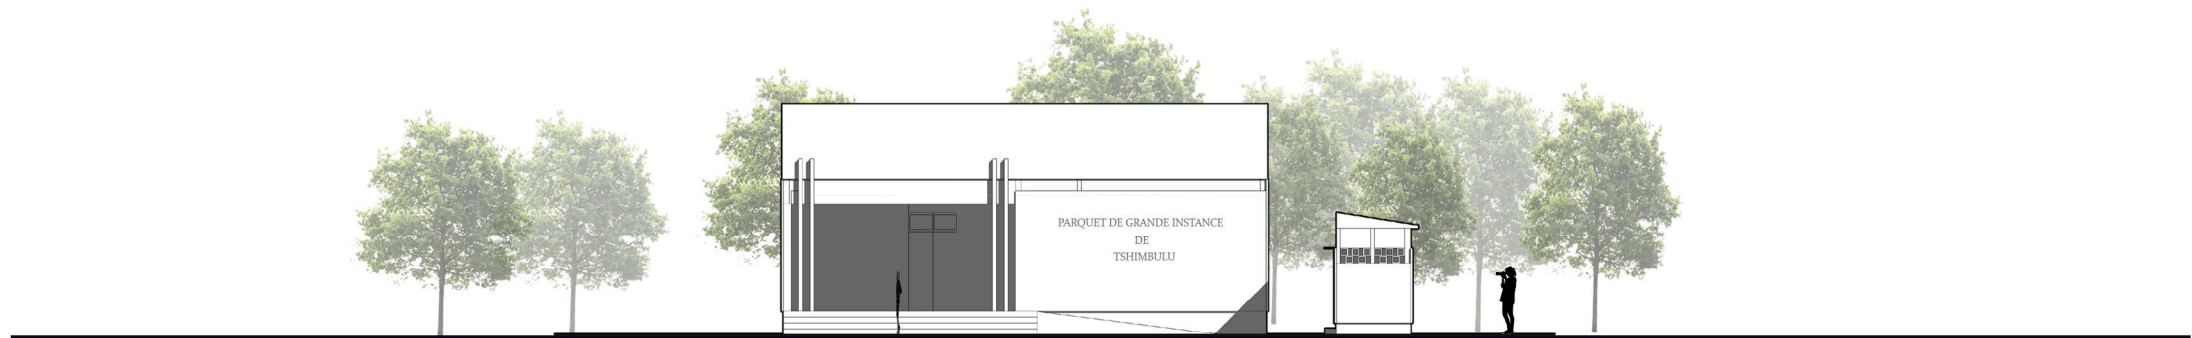

façade principale

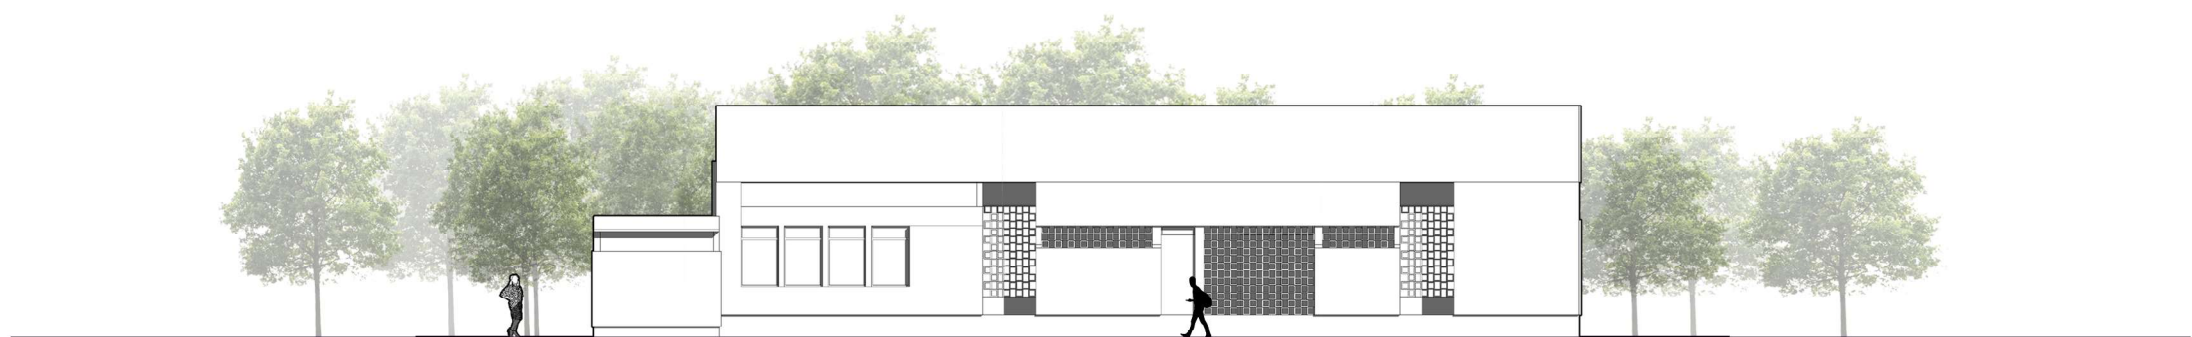

façade latérale droite



façade posterieure



façade latérale gauche

SITE KEY PLAN

REVISION RECORD			
No2	Date Drawn	DESCRIPTION	
22/06/21			
DRAWN BY	REGISTRATION NO	DATE	SIGNATURE
CHECKED BY	REGISTRATION NO	DATE	SIGNATURE
APPROVED BY	REGISTRATION NO	DATE	SIGNATURE

CLIENT:

IMPLEMENTING AGENT:



Empowered lives.
Resilient nations.

DRAWING DESCRIPTION			
PARQUET DE GRANDE INSTANCE DE TSHIMBULU R.D.CONGO			
FACADES			
ECHELLE: 1/200		BOARD NUMBER: 15	
DATE	OCTOBER 2021	SCALE	AS SHOWN
DRW NO.	PAL/BT/2021/201	DRAWN	M A K
		SIZE	A3