

Project Name : ANTI-NARCOTIC FORCE ACADEMY
EXTENSION AND WOMEN'S HOSTEL

Client : UNITED NATIONS DEVELOPMENT
PROGRAMME

Funding Agency : INTERNATIONAL NARCOTICS AND LAW
ENFORCEMENT AFFAIRS (INL)

TOTAL PLOT AREA = 8957.68 Sft.

COVERED AREA

BASEMENT = 5637.00 Sft.

GROUND FLOOR = 5742.00 Sft.

1ST FLOOR = 5742.00 Sft.

2nd FLOOR = 5937.00 Sft.

3rd FLOOR = 6087.00 Sft.

MUMTY FLOOR = 328.00 Sft.

TOTAL COVERED AREA = 29473.00 Sft.



FRONT ELEVATION



BACK ELEVATION

ARCHITECTURE DRAWINGS

S.NO	DESCRIPTION	
01	SCHEDULE OF INTERNAL FINISHES	(AR-00)
02	MASTER PLAN	(AR-01)
03	EXISTING SITE PLAN	(AR-01A)
04	SITE PLAN	(AR-01B)
05	Working Drawing Of Basement Floor Plan	(AR-02)
06	Working Drawing Of Ground Floor Plan	(AR-03)
07	Working Drawing Of First Floor Plan	(AR-04)
08	Working Drawing Of 2nd Floor Plan	(AR-05)
09	Working Drawing Of 3rd Floor Plan	(AR-06)
10	Working Drawing Of Top Roof Floor Plan	(AR-07)
11	Front Elevation	(AR-08)
12	Back Side Elevation	(AR-09)
13	Section At A-A	(AR-10)
14	Section At B-B & C-C	(AR-11)
15	Stairs & Railing Detail	(AR-12)
16	Ramp & Garage Door Detail	(AR-13)
17	Bathroom & Lavatory Detail	(AR-14)
18	Doors Window Detail	(AR-15)
19	Kitchen Detail	(AR-16)
20	Kitchen Detail	(AR-16A)
21	First floor furniture layout	(AR-17)
22	2nd floor furniture layout	(AR-18)
23	3rd floor furniture layout	(AR-19)
24	Basement floor flooring Detail	(AR-20)
25	Ground floor flooring Detail	(AR-21)
26	First floor flooring Detail	(AR-22)
27	2nd floor flooring Detail	(AR-23)
28	3rd floor flooring Detail	(AR-24)
29	Basement Floor Ceiling layout Plan	(AR-25)
30	Ground Floor Ceiling layout Plan	(AR-26)
31	First Floor Ceiling layout Plan	(AR-27)
32	2nd Floor Ceiling layout Plan	(AR-28)
33	3rd Floor Ceiling layout Plan	(AR-29)
34	Basement Paint Detail	(AR-30)
35	Ground Floor Paint Detail	(AR-31)
36	First Floor Paint Detail	(AR-32)
37	2nd Floor Paint Detail	(AR-33)
38	3rd Floor Paint Detail	(AR-34)

STRUCTURE DRAWINGS

S.NO	DESCRIPTION	
01	General Notes-1	(STR-I)
02	General Notes-2	(STR-II)
03	General Notes-3	(STR-III)
04	Basement Floor Column Plan	(STR-01)
05	Ground Floor Column Plan	(STR-02)
06	First Floor Column key Plan	(STR-03)
07	Second Floor Column key Plan	(STR-04)
08	Third Floor Column key Plan	(STR-05)
09	Excavation & foundation plan	(STR-06)
10	Foundation Additional Bottom Bar detail	(STR-07)
11	Foundation Bottom Bars detail	(STR-08)
12	Foundation Top Bars detail	(STR-09)
13	Raft Foundation Sections	(STR-10)
14	RCC Shear wall detail and Sump pit detail	(STR-11)
15	Typical Lift detail	(STR-12)
16	Column X section details	(STR-13)
17	Typical Reinforcement detail of Stairs	(STR-14)
18	Basement floor Beam key plan	(STR-15)
19	Basement floor Beam details	(STR-16)
20	Basement floor slab Reinforcement	(STR-17)
21	Basement floor slab Reinforcement	(STR-18)
22	Ground floor Beam elevations	(STR-19)
23	Ground floor slab Reinforcement	(STR-20)
24	Ground floor slab Reinforcement	(STR-21)
25	First floor Beam key plan	(STR-22)
26	First floor slab Reinforcement	(STR-23)
27	First floor slab Reinforcement	(STR-24)
28	Second floor Beam key plan	(STR-25)
29	Second floor slab Reinforcement	(STR-26)
30	Second floor slab Reinforcement	(STR-27)
31	Third floor Beam key plan	(STR-28)
32	Third floor slab Reinforcement	(STR-29)
33	Third floor slab Reinforcement	(STR-30)
34	Top floor Plan	(STR-31)
35	Ground floor Beam details	(STR-32)
36	Typical Lintel Beam details	(STR-33)
37	OHWT Section	(STR-34)

PLUMBING DRAWINGS

S.NO	DESCRIPTION	
01	LEGEND AND SEPTIC TANK	PL -01
02	PLUMBING AND BLOW UP DETAIL	PL -02
03	BASEMENT FLOOR WATER SUPPLY	PL -03
04	GROUND FLOOR WATER SUPPLY	PL -04
05	FIRST FLOOR WATER SUPPLY	PL -05
06	SECOND FLOOR WATER SUPPLY	PL -06
07	3RD FLOOR WATER SUPPLY	PL -07
08	ROOF TOP WATER SUPPLY	PL -08
09	EXTERNAL DRAINAGE	PL -09
10	BASEMENT FLOOR DRAINAGE	PL -10
11	GROUND FLOOR DRAINAGE	PL -11
12	FIRST FLOOR DRAINAGE	PL -12
13	SECOND FLOOR DRAINAGE	PL -13
14	3RD FLOOR DRAINAGE	PL -14
15	ROOF TOP DRAINAGE	PL -15
16	BASEMENT FLOOR FIRE FIGHTING	FF -01
17	GROUND FLOOR FIRE FIGHTING	FF -02
18	FIRST FLOOR FIRE FIGHTING	FF -03
19	SECOND FLOOR FIRE FIGHTING	FF -04
20	3RD FLOOR FIRE FIGHTING	FF -05
21	GROUND FLOOR GAS PLAN	GF -01
22	1ST FLOOR GAS PLAN	GS -02
23	2ND FLOOR GAS PLAN	GS -03
24	3RD FLOOR GAS PLAN	GS -04
25	BASEMENT FLOOR LIFE SAFETY	LS -01
26	GROUND FLOOR LIFE SAFETY	LS -02
27	1ST FLOOR LIFE SAFETY PLAN	LS -03
28	2ND FLOOR LIFE SAFETY PLAN	LS -04
29	3RD FLOOR LIFE SAFETY PLAN	LS -05

ELECTRICAL DRAWINGS

S.NO	DESCRIPTION	
01	LEGEND AND GENERAL NOTES	EL -00
02	LIGHTING FOR BASEMENT	EL -01
03	LIGHTING FOR GROUND FLOOR	EL -02
04	LIGHTING FOR FIRST FLOOR	EL -03
05	LIGHTING FOR SECOND FLOOR	EL -04
06	LIGHTING FOR 3RD FLOOR	EL -05
07	LIGHTING FOR MUMTY	EL -06
08	EXTERNAL ELECTRICAL	EL -07
09	BASEMENT FLOOR POWER	EL -08
10	GROUND FLOOR POWER	EL -09
11	FIRST FLOOR POWER	EL -10
12	SECOND FLOOR POWER	EL -11
13	3RD FLOOR POWER	EL -12
14	BASEMENT CO-DECTORS,FIRE ALARM AND CCTV	EL -13
15	GROUND FLOOR CO-DECTORS,FIRE ALARM AND CCTV	EL -14
16	FIRST FLOOR CO-DECTORS,FIRE ALARM AND CCTV	EL -15
17	SECOND FLOOR CO-DECTORS,FIRE ALARM AND CCTV	EL -16
18	3RD FLOOR CO-DECTORS,FIRE ALARM AND CCTV	EL -17
19	FIRST FLOOR AC	EL -18
20	SECOND FLOOR AC	EL -19
21	3RD FLOOR AC	EL -20
22	LIGHTING PROTECTION GROUND FLOOR	EL -21
23	LIGHTING PROTECTION ROOF TOP	EL -22
24	BASEMENT FLOOR PUBLIC ADDRESS	EL -23
25	GROUND FLOOR PUBLIC ADDRESS	EL -24
26	FIRST FLOOR PUBLIC ADDRESS	EL -25
27	SECOND FLOOR POWER	EL -26
28	3RD FLOOR PUBLIC ADDRESS	EL -27
29	SINGLE LINE DIAGRAM	EL -28

Project

ANTI-NARCOTIC FORCE ACADEMY
EXTENSION AND WOMEN'S HOSTEL

Client

UNITED NATIONS DEVELOPMENT PROGRAMME

Funding Agency

INTERNATIONAL NARCOTICS AND LAW
ENFORCEMENT AFFAIRS (INL)

Consultant

GSK
ENGINEERZ

GSK ENGINEERZ

PLANNING - TESTING - DESIGNING & DEVELOPMENT
FLAT NO.205 & 206 2nd Floor, Afzal Tower Phase 3,
Main Intersection, Peshawar
Ph: +92-333-912-6118, +92-334-843-5340
E.mail: gsk.engineerz@gmail.com

PROJECT
&
LOCATION
TITLE:


ANTI NARCOTICS FORCE ACADEMY
EXTENSION & WOMEN HOSTEL.

WORKING DRAWING LIST
ANTI NARCOTICS FORCE ACADEMY
EXTENSION & WOMEN HOSTEL.

DRAWING INDEX

SCHEDULE OF INTERNAL FINISHES

LEGEND

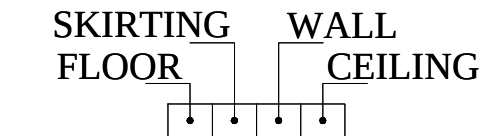

- ① PORCELAIN TILES OF APPROVED SIZE PATTERN AND COLOR.
- ② PORCELAIN SKIRTING OF APPROVED PATTERN & COLOR.
- ③ VINYL EMULSION ON C.S PLASTER (APPROVED MAKE & SHADE)
- ④ MARBLE TILES OF APPROVED PATTERN & COLOR.
- ⑤ 6'-0" TO 4'-0"x12"x3/4" TH. GRANITE SLABS
FOR TREADS OF APPROVED COLOR & PATTERN.
- ⑥ 6'-0" TO 4'-0"x12"x3/4" TH. GRANITE SLABS
SLABS FOR RISERS OF APPROVED COLOR & PATTERN.
- ⑦ 4"HIGH GRANITE SKIRTING OF APPROVED COLOR & PATTERN.
- ⑧ PORCELAIN TILES FOR BATH FLOORING OF APPROVED COLOR & PATTERN.
- ⑨ PORCELAIN TILES OF APPROVED PATTERN AND COLOR 7'-0" HIGH WITH
VINYL EMULSION PAINT ABOVE UP TO CEILING.
- ⑩ PAINT ABOVE UP TO CEILING.
- ⑪ (B) FALSE CEILING GYPSUM BOARD
- ⑫ PRE CAST INTERLOCKING CONCRETE PAVERS

- ⑬ CONCRETE EDGING OF APPROVED COLOUR & PATTERN.
- ⑭ MARBLE SKIRTING
- ⑮ DECORATIVE WALL
- ⑯ DECORATIVE PLASTIC PARIC CEILING
- ⑰ TERRAZZO FLOOR APPROVED PATTERN AND COLOR.
- ⑱ TERRAZZO SKIRTING OF APPROVED PATTERN & COLOR.
- ⑲ WEATHER SHIELD PAINT OF APPROVED MAKE & COLOR.
- ⑳ GRANITE TILES OF APPROVED SIZE PATTERN AND COLOR.
- ㉑ GRANITE SKIRTING OF APPROVED PATTERN & COLOR.
- ㉒ GRANITE TILES OF APPROVED SIZE PATTERN AND COLOR UP TO CEILING .
- ㉓ FALSE CEILING PLASTER OF PARIS
- ㉔ TERRAZZO SLABS FOR TREAD & RISER.


Project
ANTI-NARCOTIC FORCE ACADEMY
EXTENSION AND WOMEN'S HOSTEL

Client
UNITED NATIONS DEVELOPMENT PROGRAMME
Funding Agency
INTERNATIONAL NARCOTICS AND LAW
ENFORCEMENT AFFAIRS (INL)

Consultant
GSK ENGINEERZ
PLANNING - TESTING - DESIGNING & DEVELOPMENT
FLAT NO.205 & 206 2nd Floor, Afzal Tower Phase 3,
Main Intersection, Peshawar
Ph: +92-333-912-6118, +92-334-843-5340
E.mail: gsk.engineerz@gmail.com

SCALE : N.T.S	ARCHITECT : M.IQBAL
SHEET NO: AR - 00	PREPARED BY : GHANI REHMAN
DATE : AUG - 2021	DRAWING TITLE: SCHEDULE OF INTERNAL FINISHES
ARCHITECTURAL DRAWING	



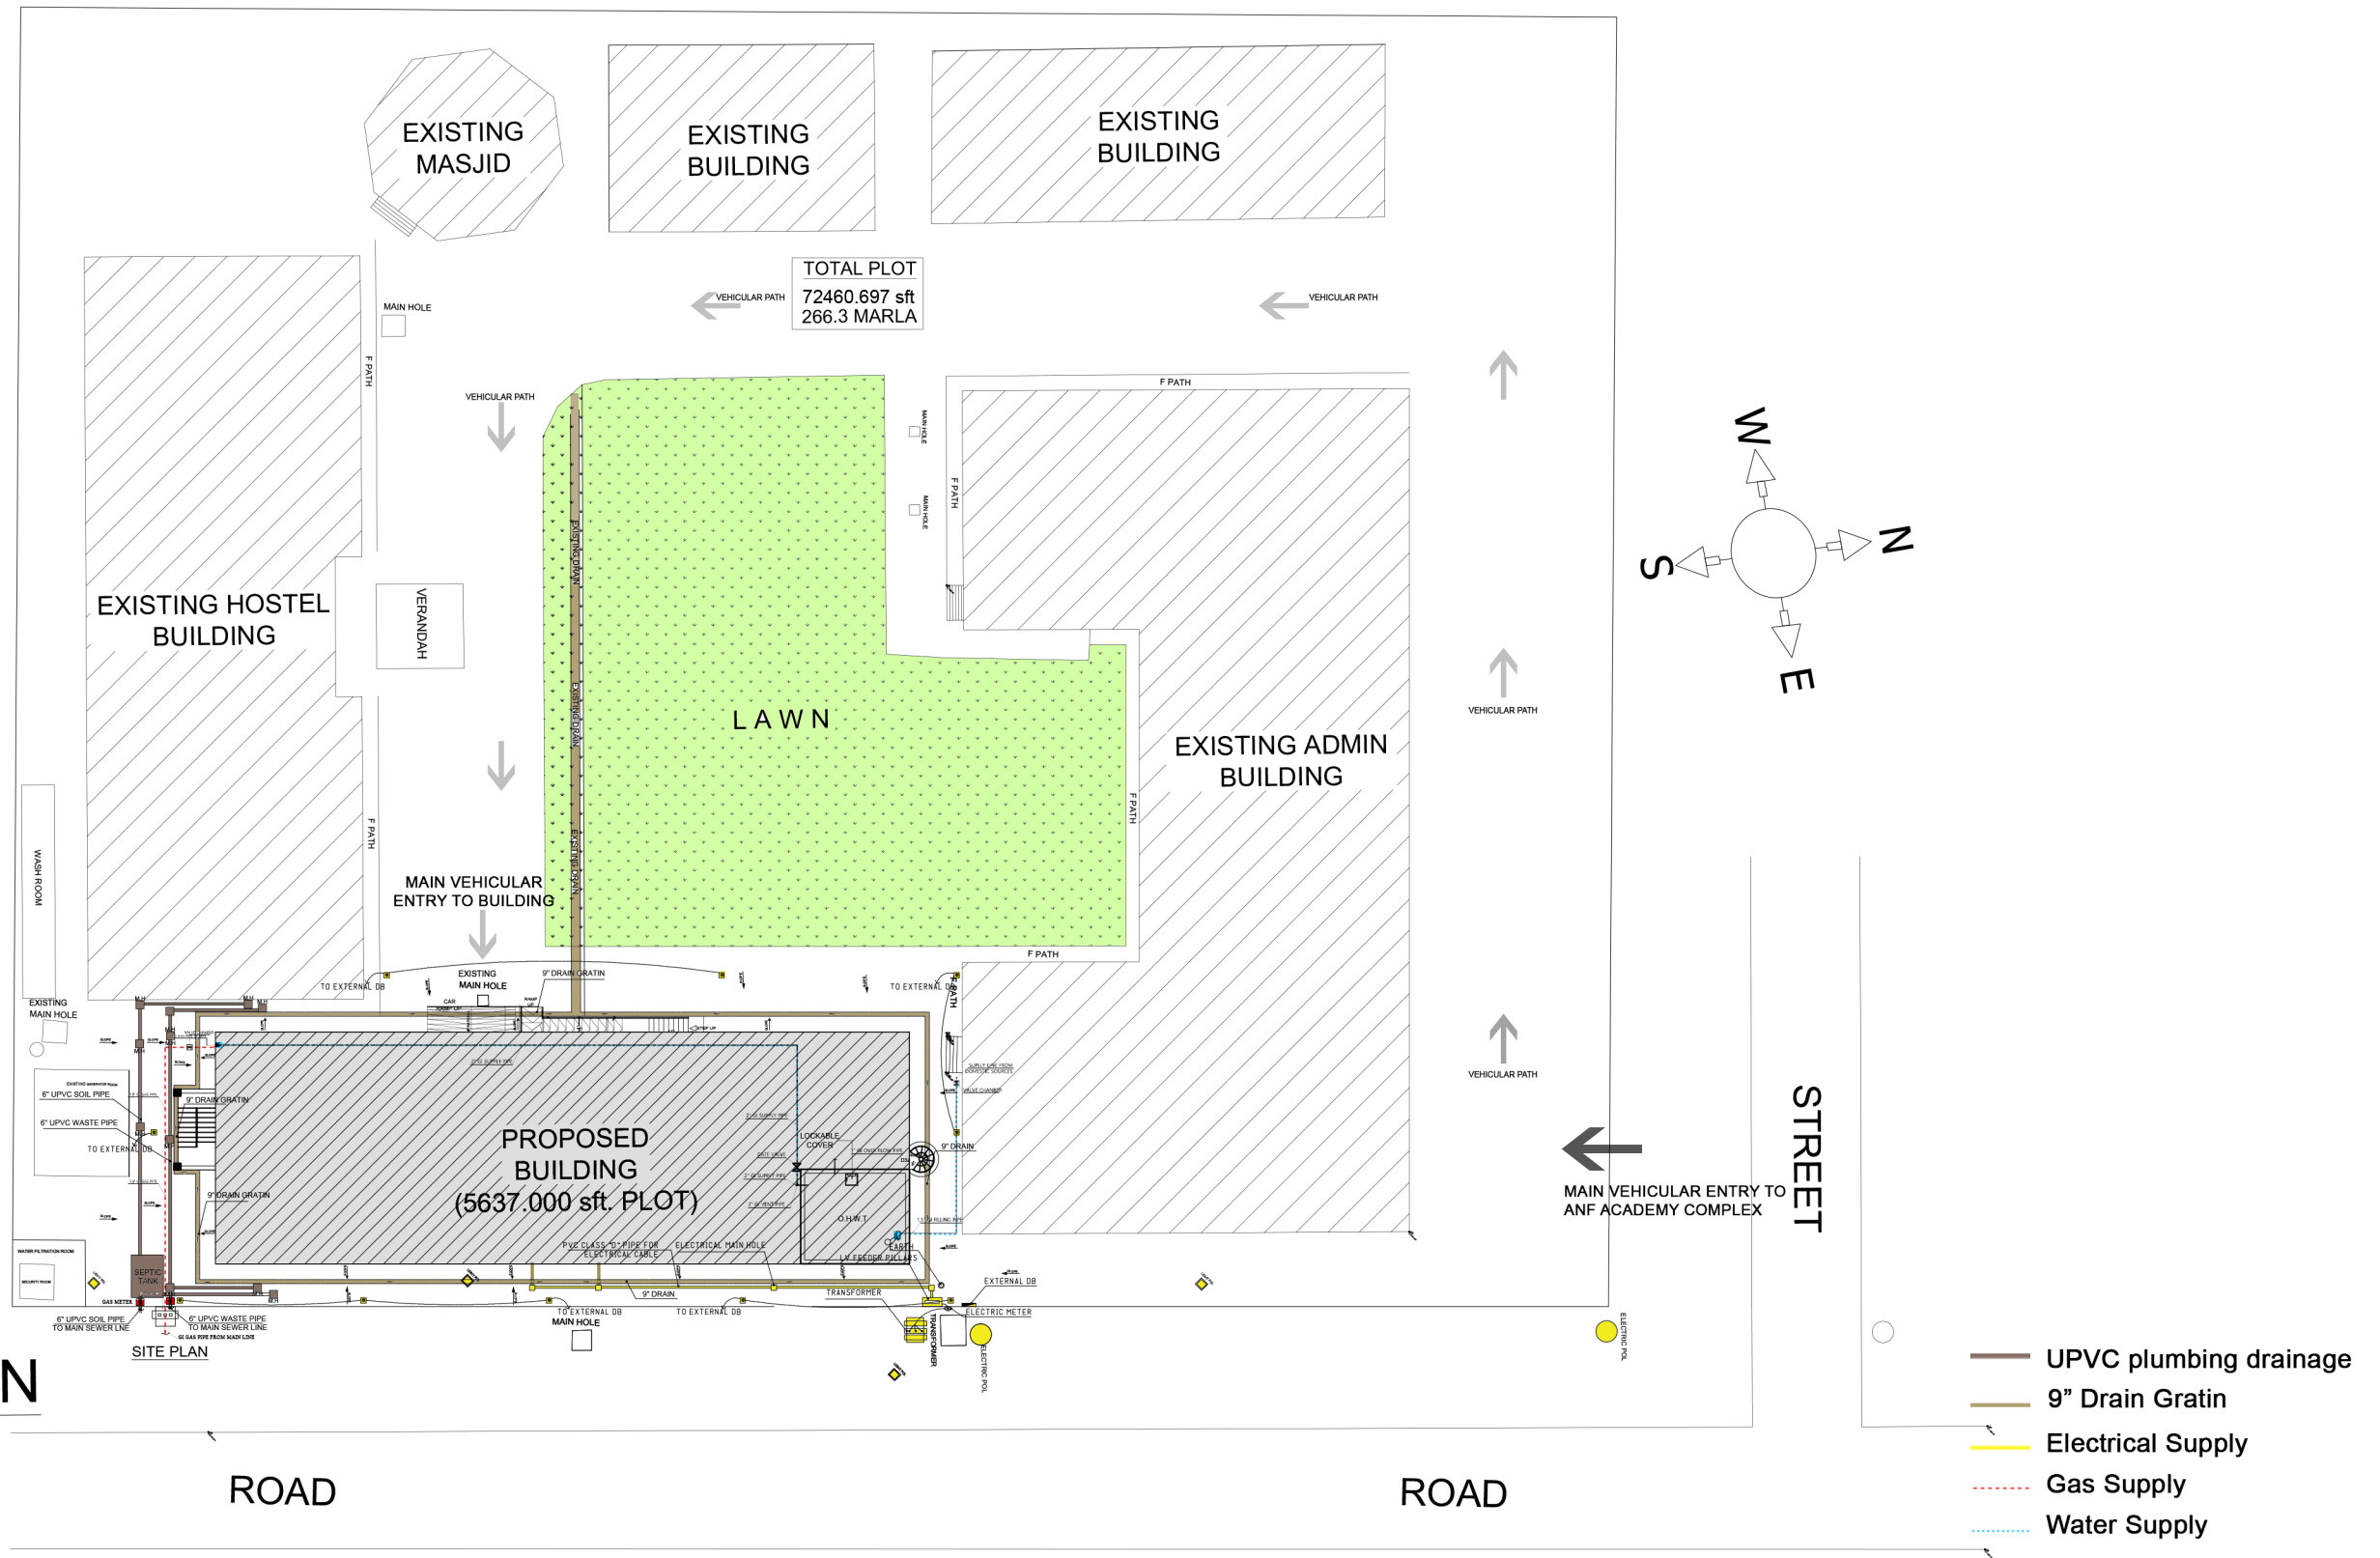

MASTER PLAN

Project

ANTI-NARCOTIC FORCE ACADEMY
EXTENSION AND WOMEN'S HOSTEL

Client

UNITED NATIONS DEVELOPMENT PROGRAMME

Funding Agency

INTERNATIONAL NARCOTICS AND LAW
ENFORCEMENT AFFAIRS (INL)



Consultant

GSK ENGINEERZ

PLANNING - TESTING - DESIGNING & DEVELOPMENT
FLAT NO.205 & 206 2nd Floor, Afzal Tower Phase 3,
Main Intersection, Peshawar
Ph: +92-333-912-6118, +92-334-843-5340
E.mail: gsk.engineerz@gmail.com

SCALE : N.T.S	ARCHITECT : M.IQBAL
SHEET NO : ST-AR-01	PREPARED BY : GHANI REHMAN
DATE : AUG -2021	DRAWING TITLE : MASTER PLAN
ARCHITECTURAL DRAWING	



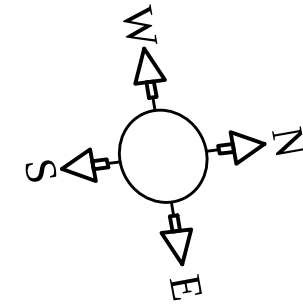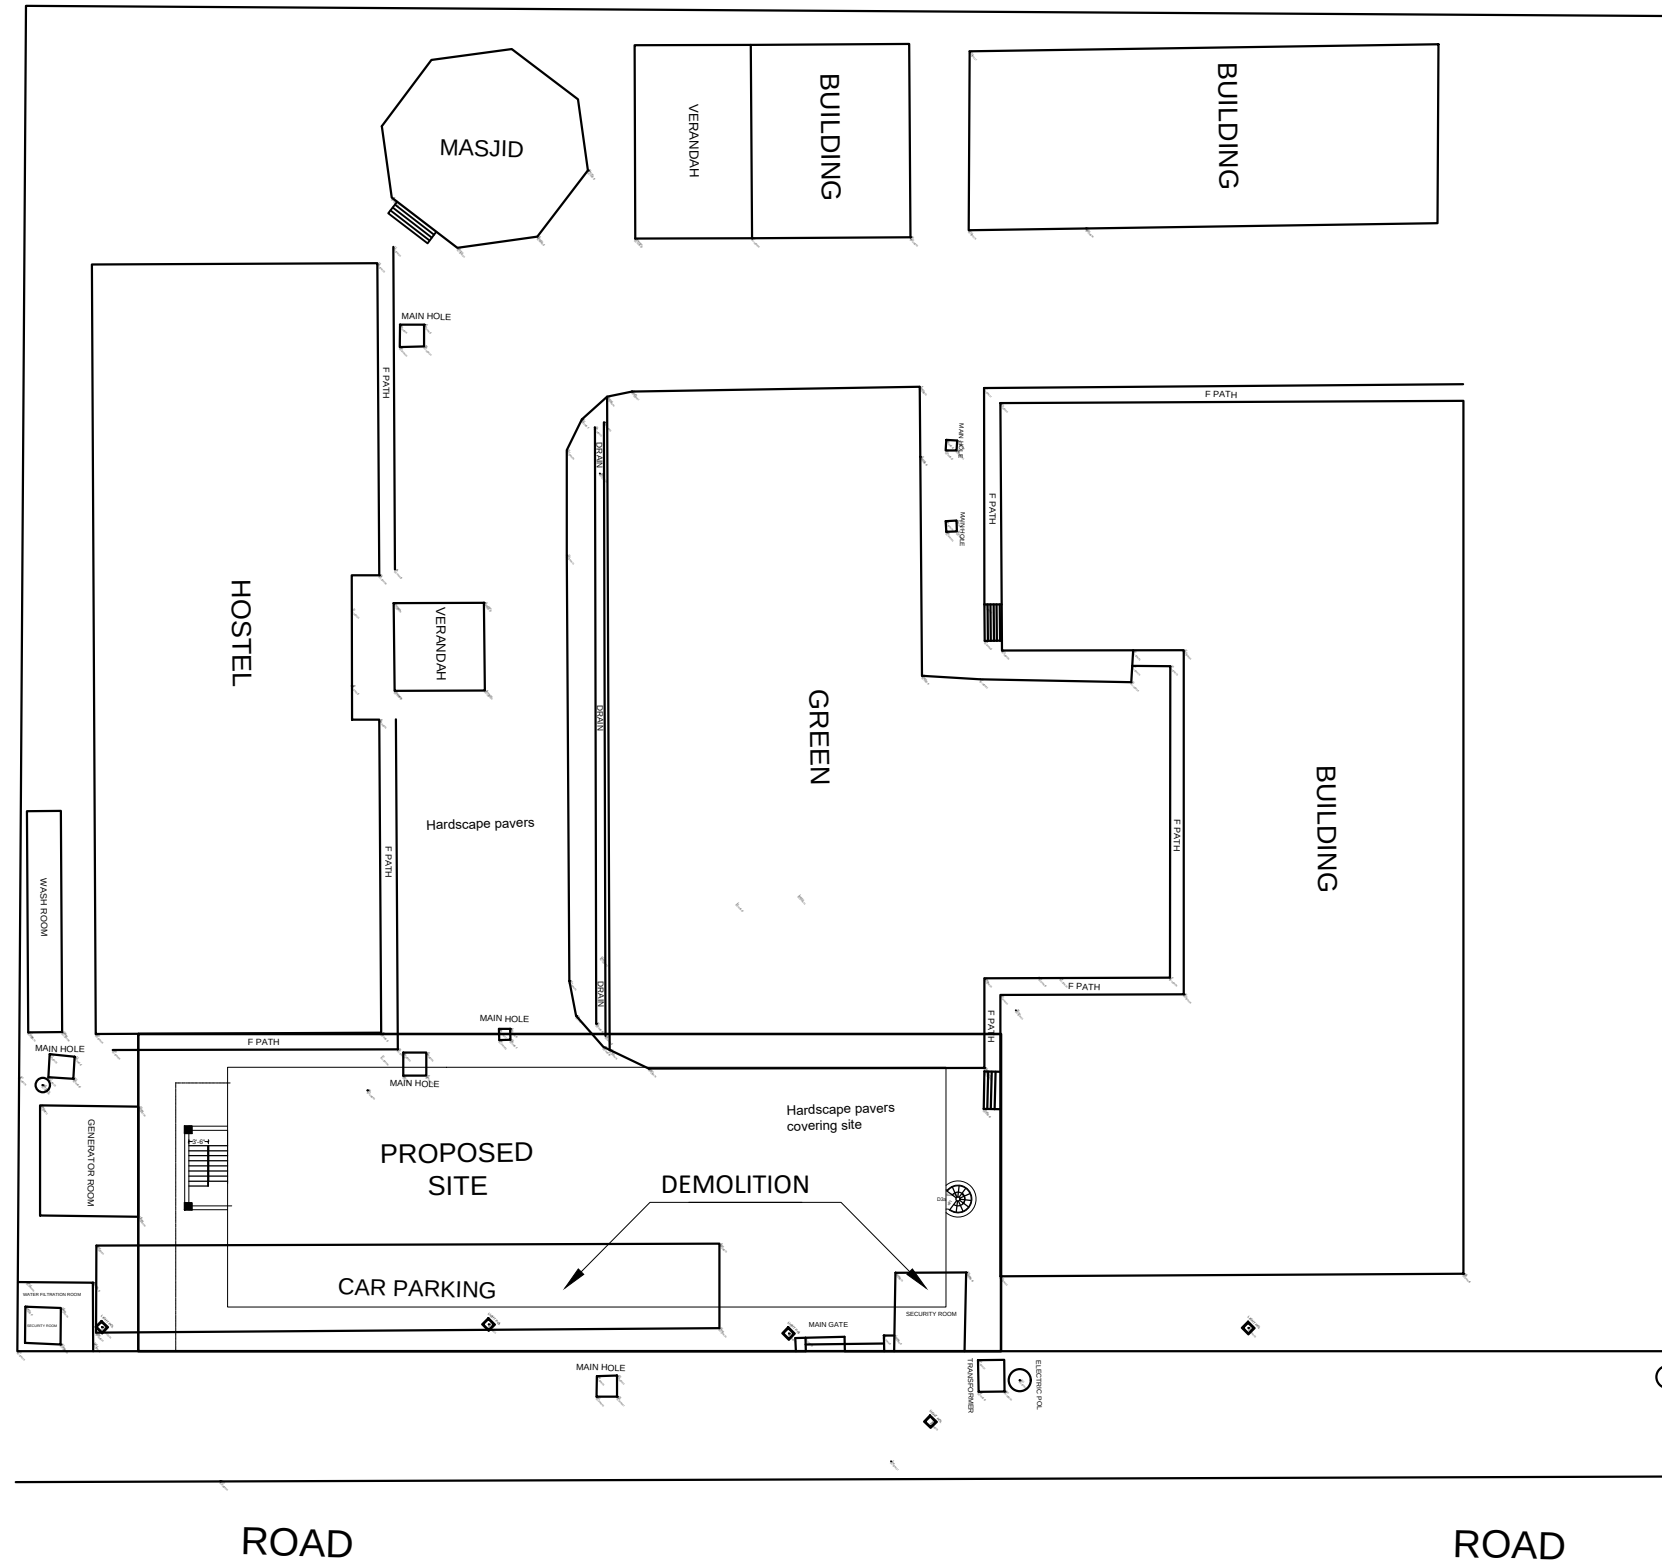

SITE PLAN

PICTURES OF SITE

Project

ANTI-NARCOTIC FORCE ACADEMY
EXTENSION AND WOMEN'S HOSTEL

Client

UNITED NATIONS DEVELOPMENT PROGRAMME

Funding Agency


INTERNATIONAL NARCOTICS AND LAW
ENFORCEMENT AFFAIRS (INL)


Consultant

GSK ENGINEERZ

PLANNING - TESTING - DESIGNING & DEVELOPMENT
FLAT NO.205 & 206 2nd Floor, Afzal Tower Phase 3,
Main Intersection, Peshawar
Ph: +92-333-912-6118, +92-334-843-5340
E.mail: gsk.engineerz@gmail.com

SCALE :	N.T.S	ARCHITECT :	M.IQBAL
SHEET NO:	ST-AR-01A	PREPARED BY :	GHANI REHMAN
DATE :	AUG - 2021	DRAWING TITLE:	SITE PLAN
ARCHITECTURAL DRAWING			

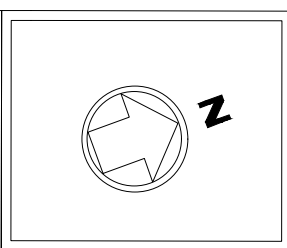

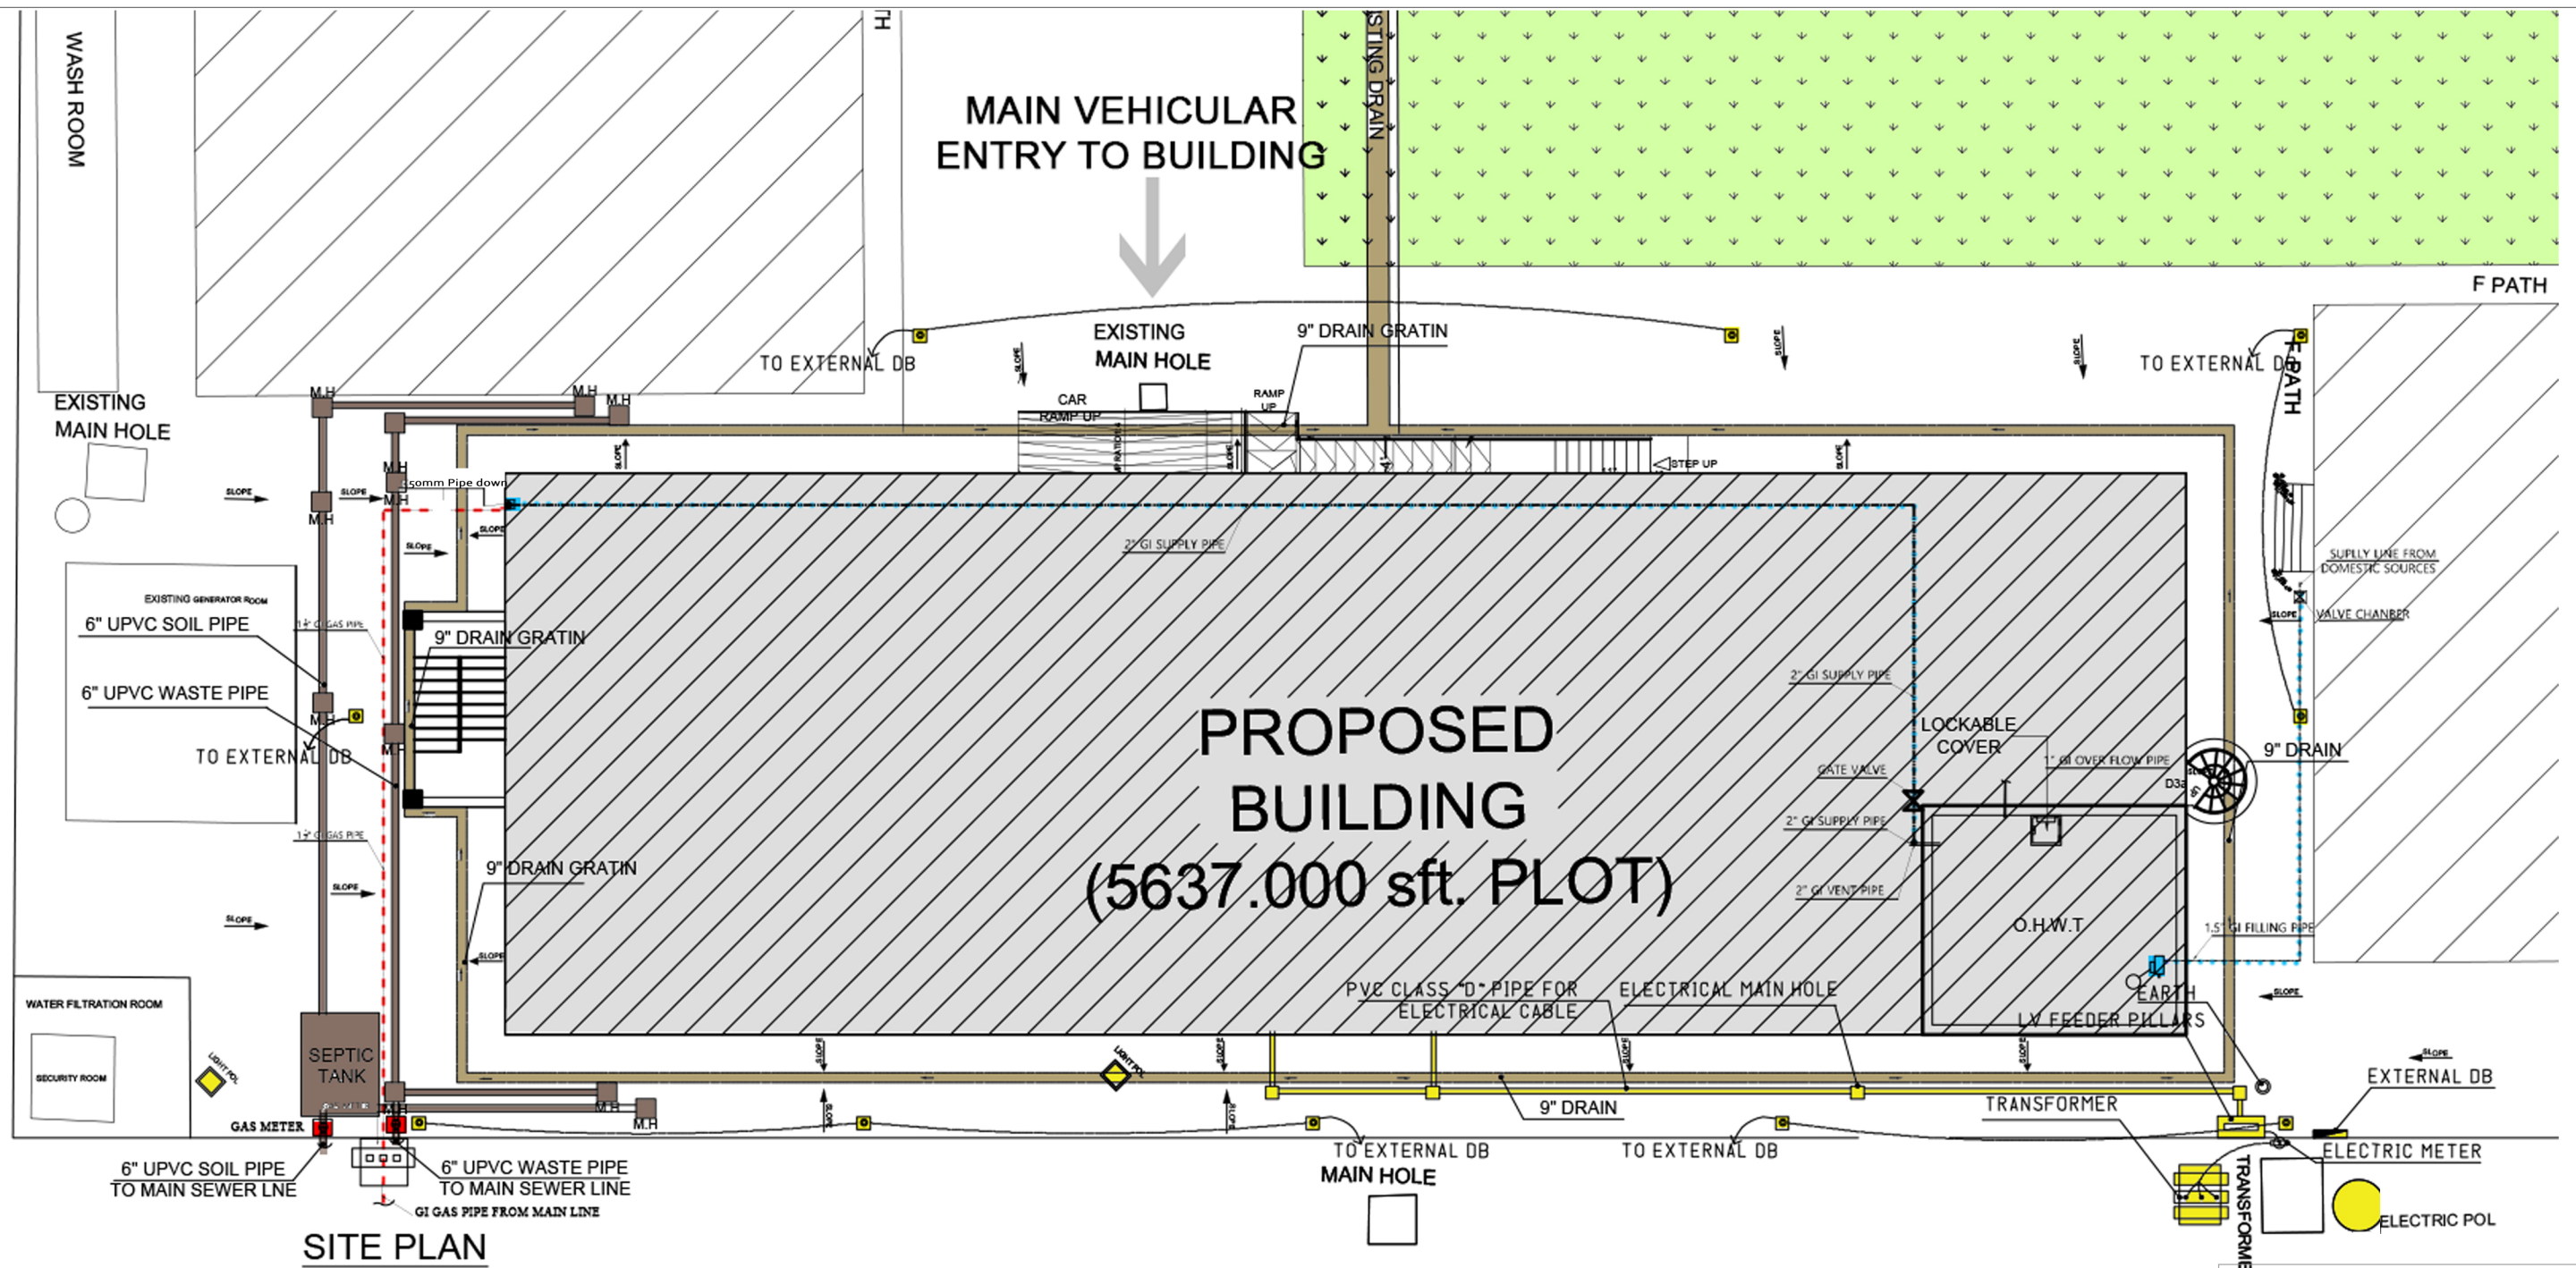

SITE PLAN

- LEGEND**
- UPVC plumbing drainage
 - 9" Drain Gratin
 - Electrical Supply
 - Gas Supply
 - Water Supply

ROAD

Project

ANTI-NARCOTIC FORCE ACADEMY
EXTENSION AND WOMEN'S HOSTEL

Client

UNITED NATIONS DEVELOPMENT PROGRAMME

Funding Agency

INTERNATIONAL NARCOTICS AND LAW
ENFORCEMENT AFFAIRS (INL)


Consultant

GSK ENGINEERZ

PLANNING - TESTING - DESIGNING & DEVELOPMENT
FLAT NO.205 & 206 2nd Floor, Afzal Tower Phase 3,
Main Intersection, Peshawar
Ph: +92-333-912-6118, +92-334-843-5340
E.mail: gsk.engineerz@gmail.com

SCALE :	N.T.S	ARCHITECT :	M.IQBAL
SHEET NO :	ST-AR-01B	PREPARED BY :	GHANI REHMAN
DATE :	AUG -2021	DRAWING TITLE :	SITE PLAN
ARCHITECTURAL DRAWING			



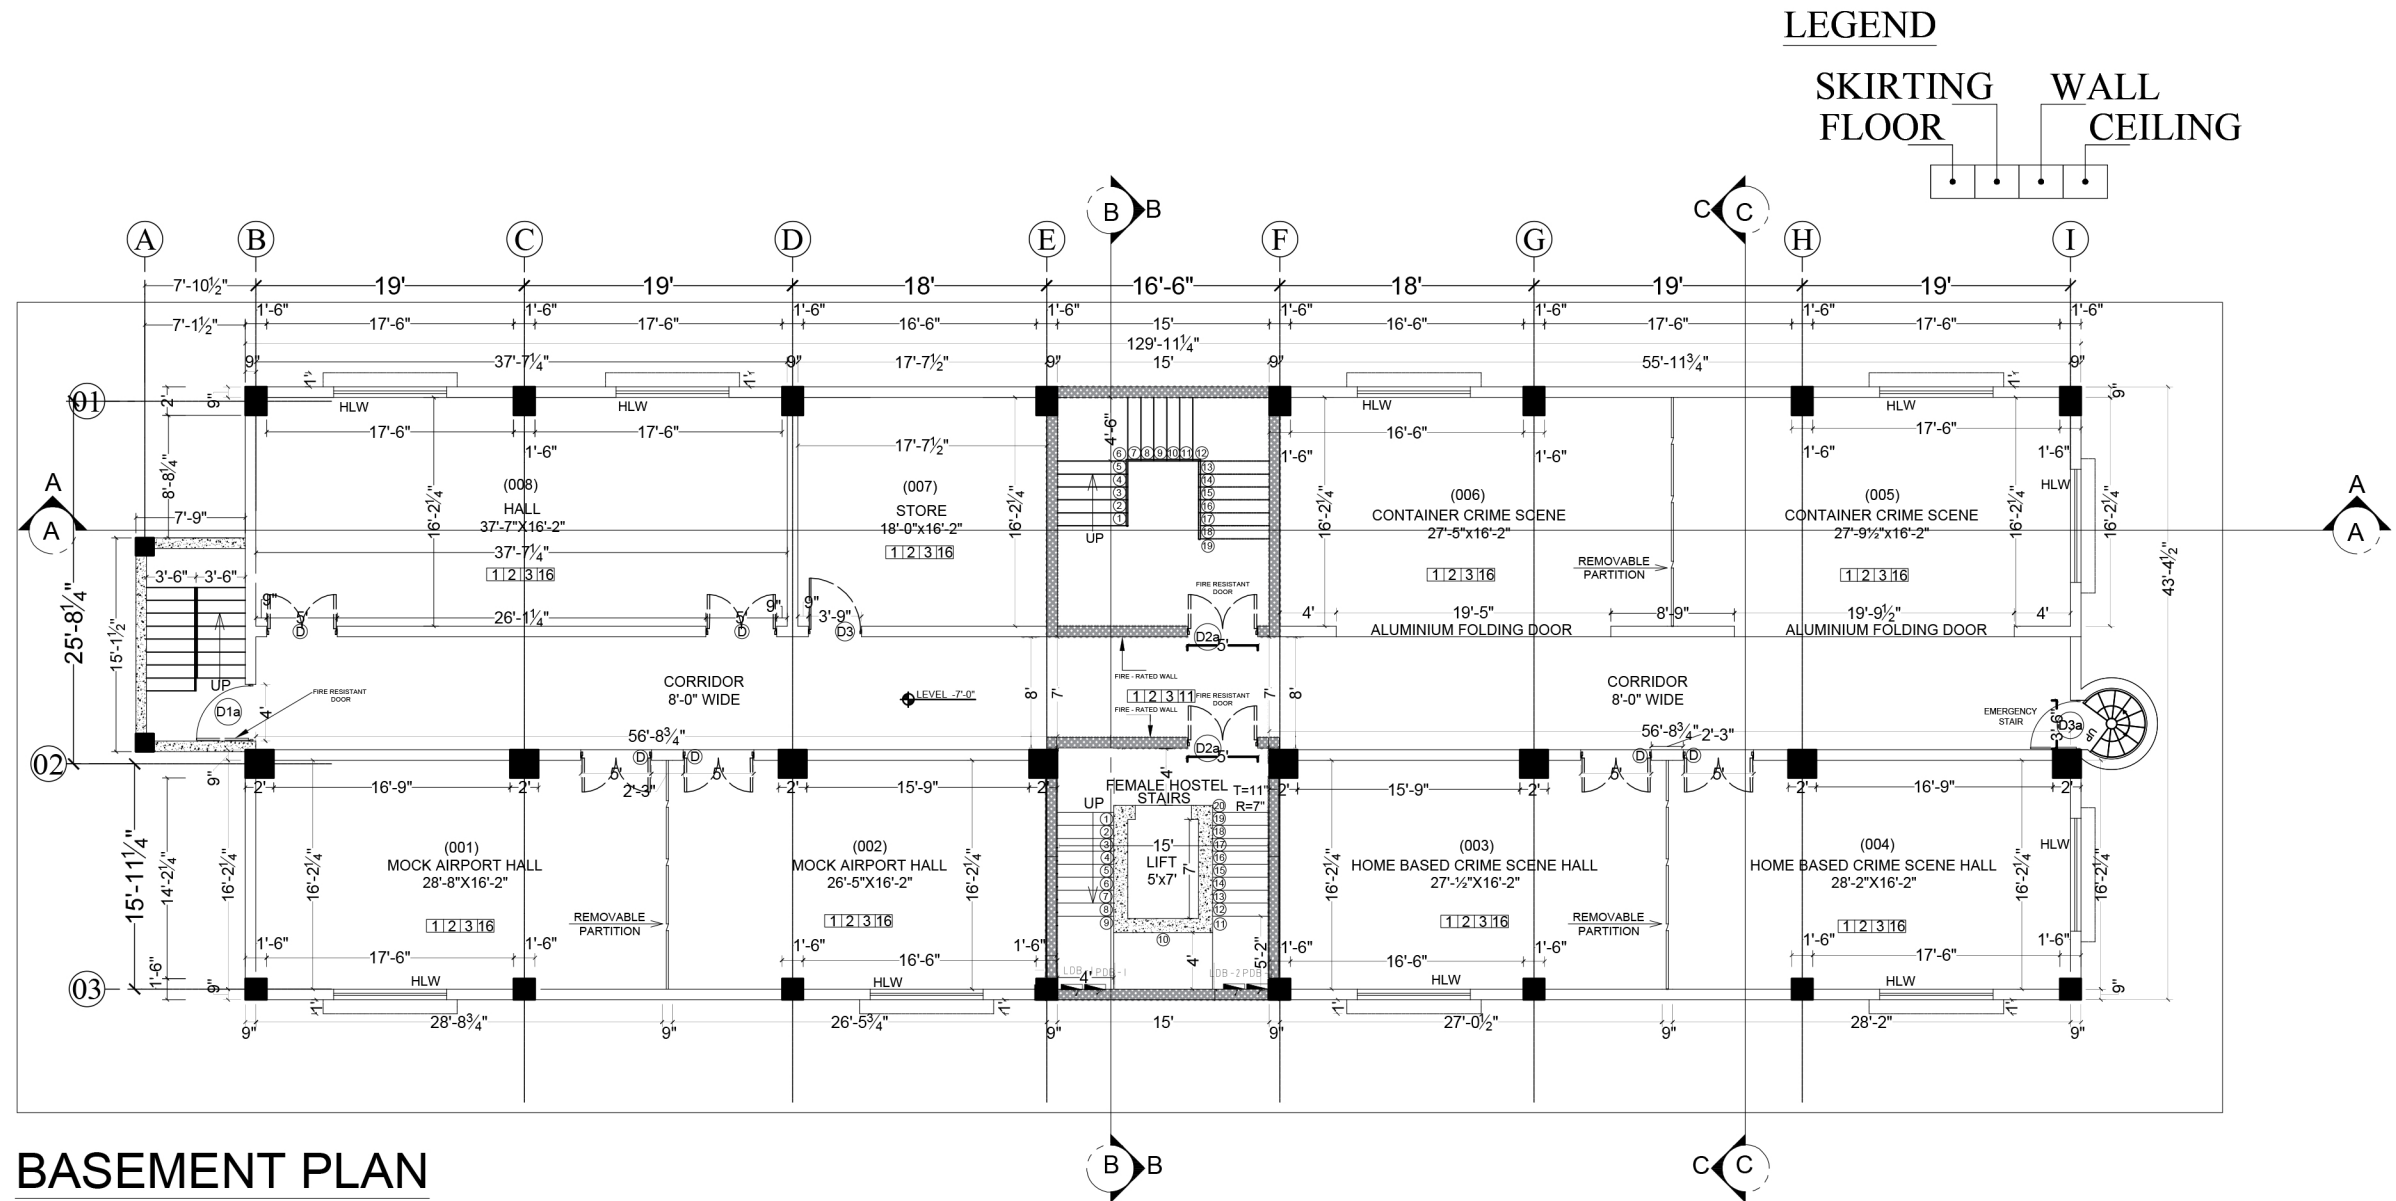

Project

ANTI-NARCOTIC FORCE ACADEMY
EXTENSION AND WOMEN'S HOSTEL


Client

UNITED NATIONS DEVELOPMENT PROGRAMME

Funding Agency

INTERNATIONAL NARCOTICS AND LAW
ENFORCEMENT AFFAIRS (INL)

Consultant

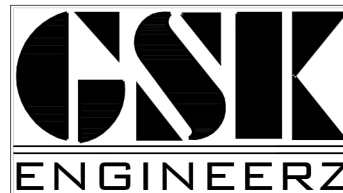


GSK ENGINEERZ

PLANNING - TESTING - DESIGNING & DEVELOPMENT
FLAT NO.205 & 206 2nd Floor, Afzal Tower Phase 3,
Main Intersection, Peshawar
Ph: +92-333-912-6118, +92-334-843-5340
E.mail: gsk.engineerz@gmail.com

SCALE :	N.T.S	ARCHITECT :	M.IQBAL
SHEET NO:	AR - 02	PREPARED BY :	GHANI REHMAN
DATE :	AUG - 2021	DRAWING TITLE:	BASEMENT PLAN

ARCHITECTURAL DRAWING



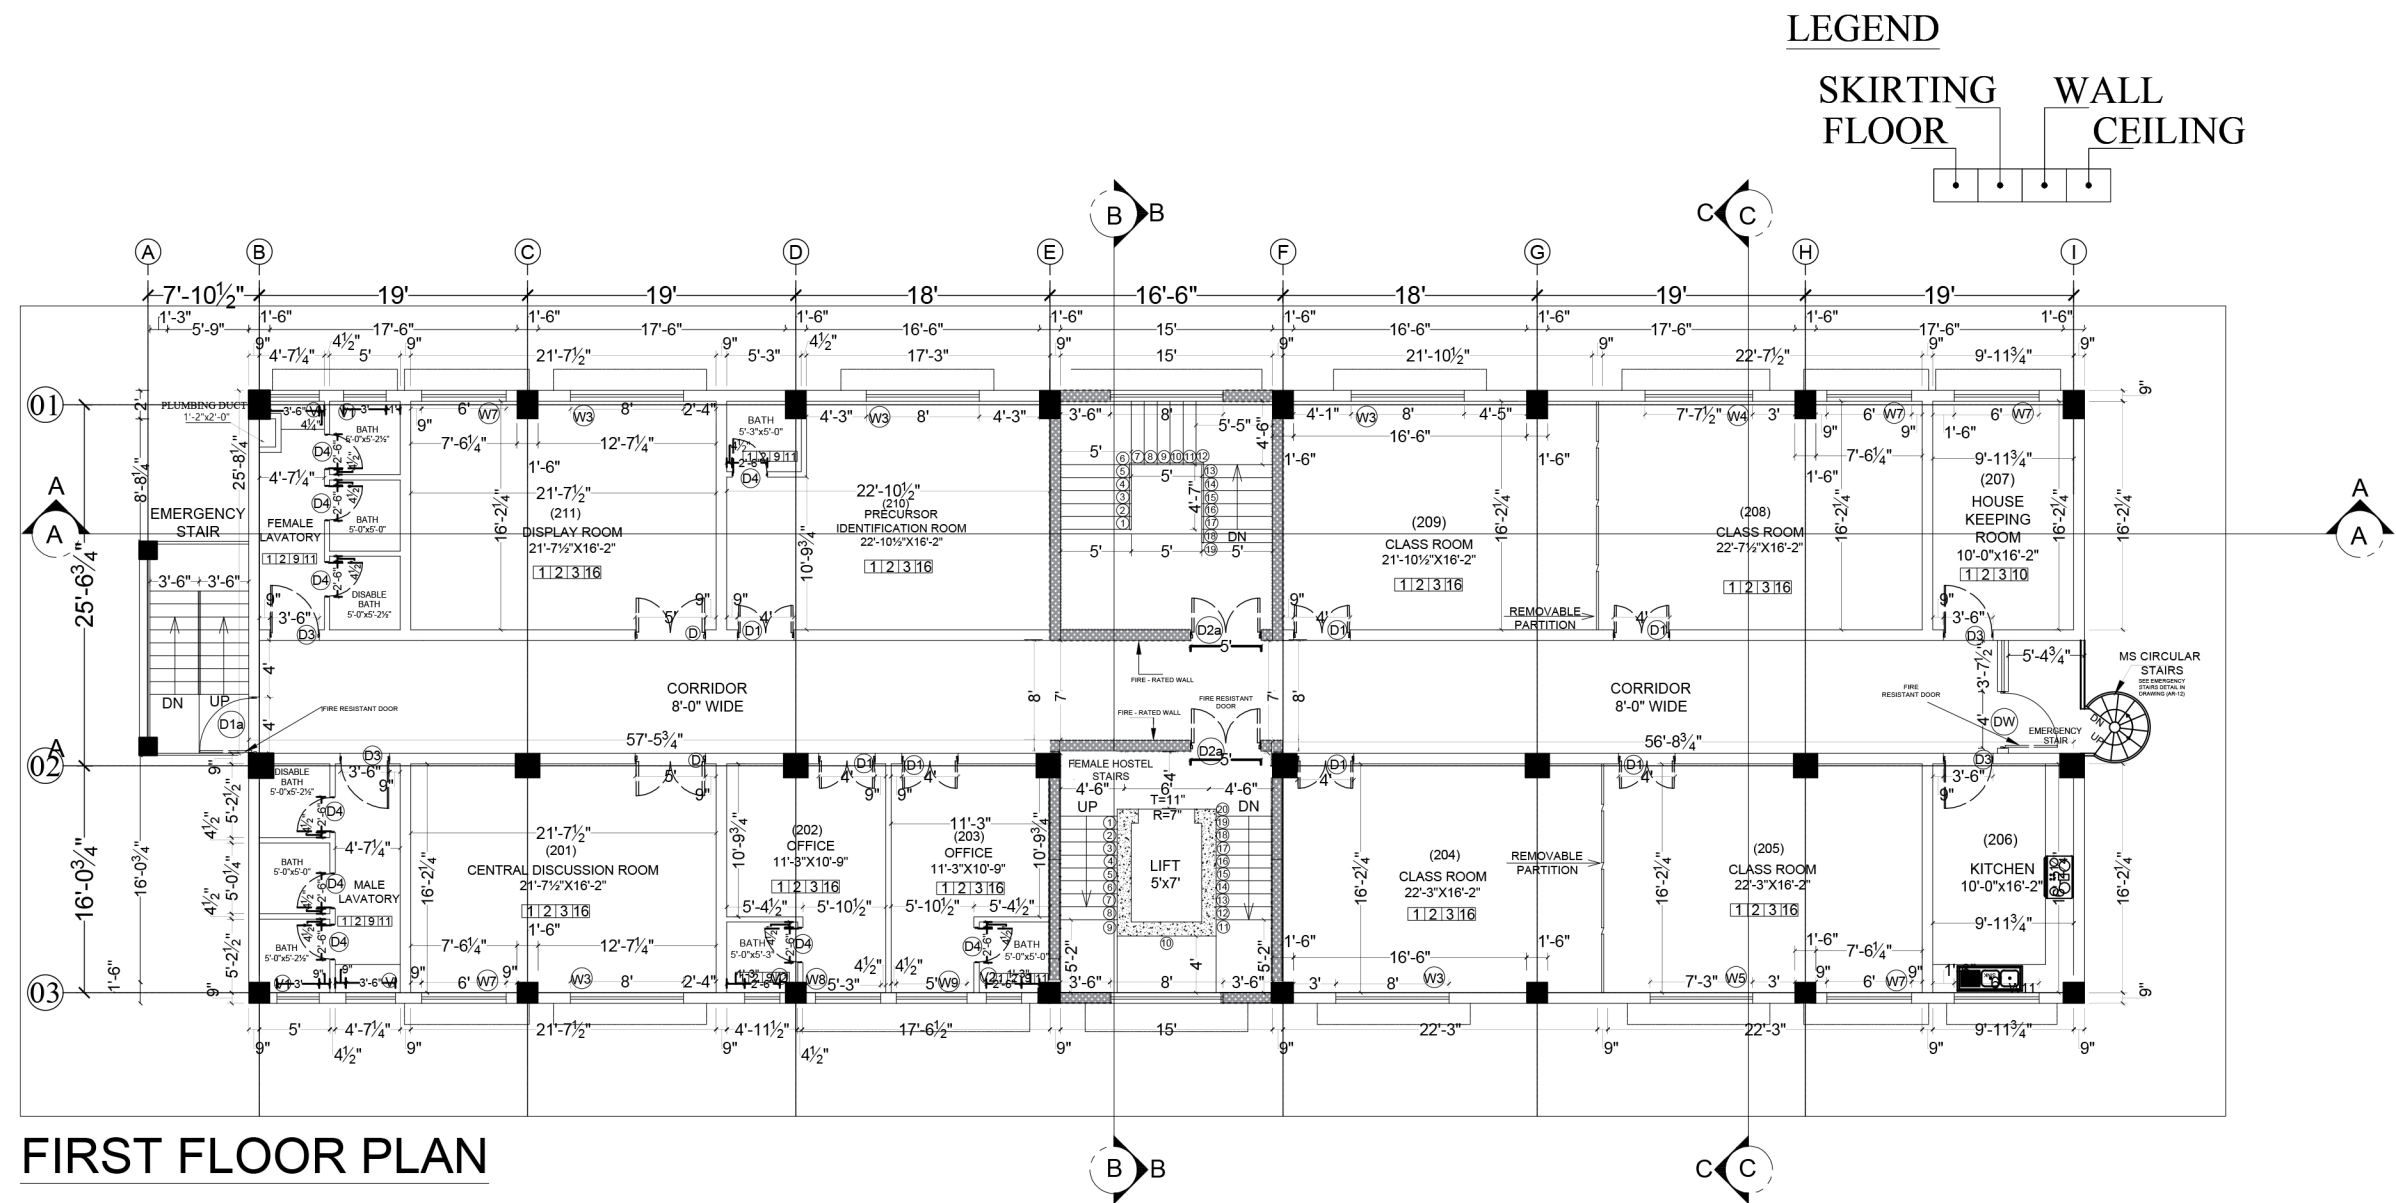

Project

ANTI-NARCOTIC FORCE ACADEMY
EXTENSION AND WOMEN'S HOSTEL


Client

UNITED NATIONS DEVELOPMENT PROGRAMME

Funding Agency

INTERNATIONAL NARCOTICS AND LAW
ENFORCEMENT AFFAIRS (INL)

Consultant

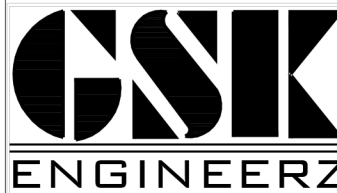


GSK ENGINEERZ

PLANNING - TESTING - DESIGNING & DEVELOPMENT
FLAT NO.205 & 206 2nd Floor, Atzal Tower Phase 3,
Main Intersection, Peshawar
Ph: +92-333-912-6118, +92-334-843-5340
E-mail: gsk.engineerz@gmail.com

SCALE : N.T.S	ARCHITECT : M.IQBAL	
SHEET NO : AR - 04	PREPARED BY : GHANI REHMAN	
DATE : AUG - 2021	DRAWING TITLE : FIRST FLOOR PLAN	
ARCHITECTURAL DRAWING		



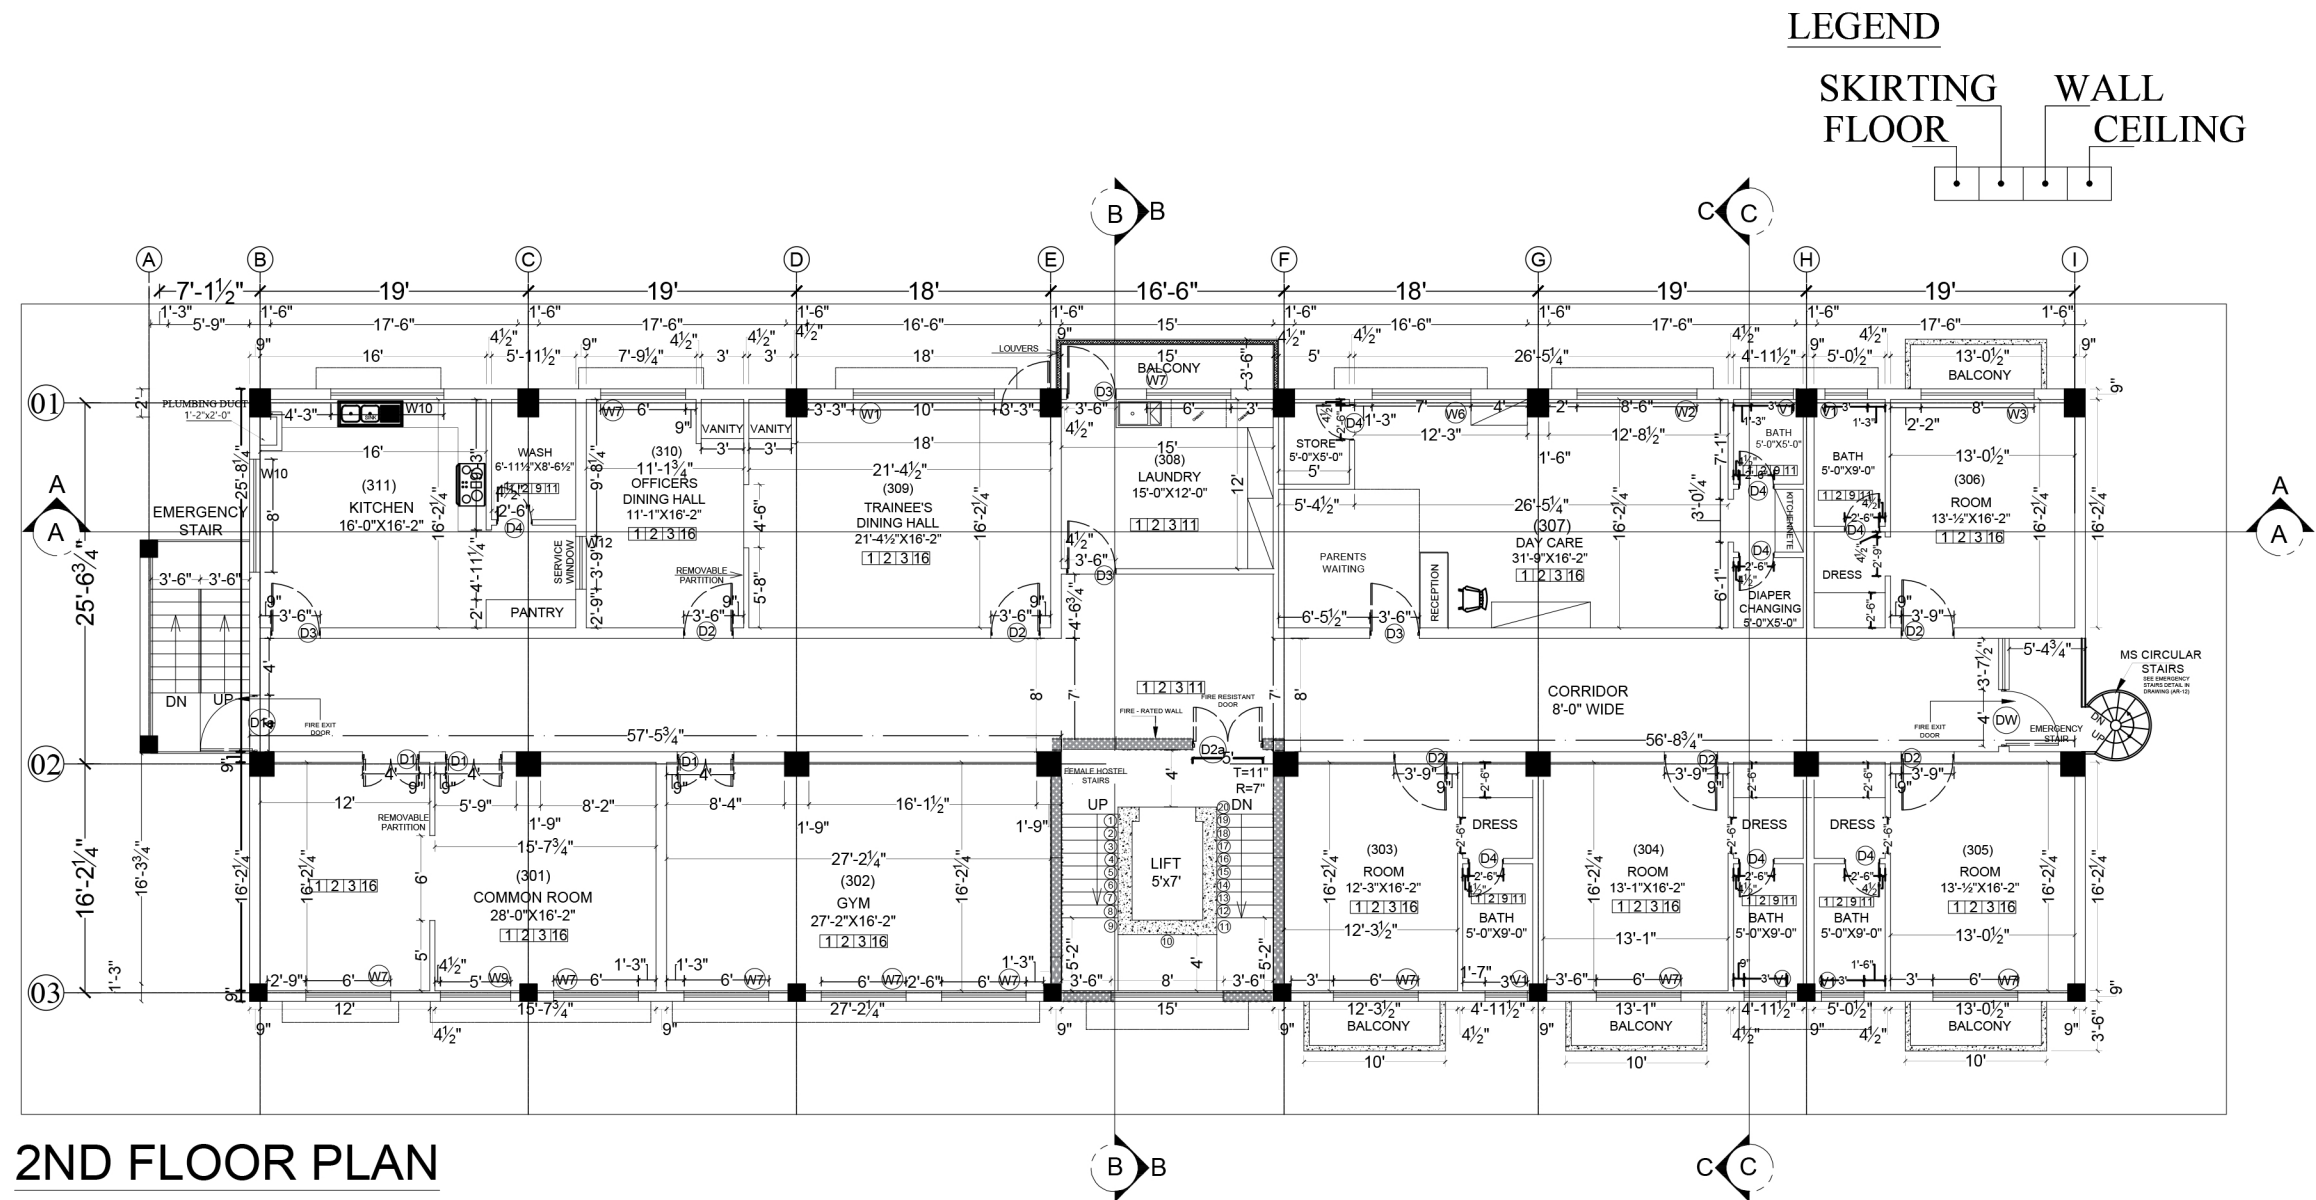

Project

ANTI-NARCOTIC FORCE ACADEMY
EXTENSION AND WOMEN'S HOSTEL


Client

UNITED NATIONS DEVELOPMENT PROGRAMME

Funding Agency

INTERNATIONAL NARCOTICS AND LAW
ENFORCEMENT AFFAIRS (INL)

Consultant

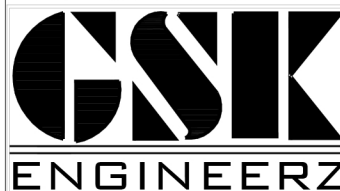


GSK ENGINEERZ

PLANNING - TESTING - DESIGNING & DEVELOPMENT
FLAT NO.205 & 206 2nd Floor, Afzal Tower Phase 3,
Main Intersection, Peshawar
Ph: +92-333-912-6118, +92-334-843-5340
E-mail: gsk.engineerz@gmail.com

SCALE : N.T.S	ARCHITECT : M.IQBAL	
SHEET NO: AR - 05	PREPARED BY : GHANI REHMAN	
DATE : AUG - 2021	DRAWING TITLE:	SECOND FLOOR PLAN
ARCHITECTURAL DRAWING		



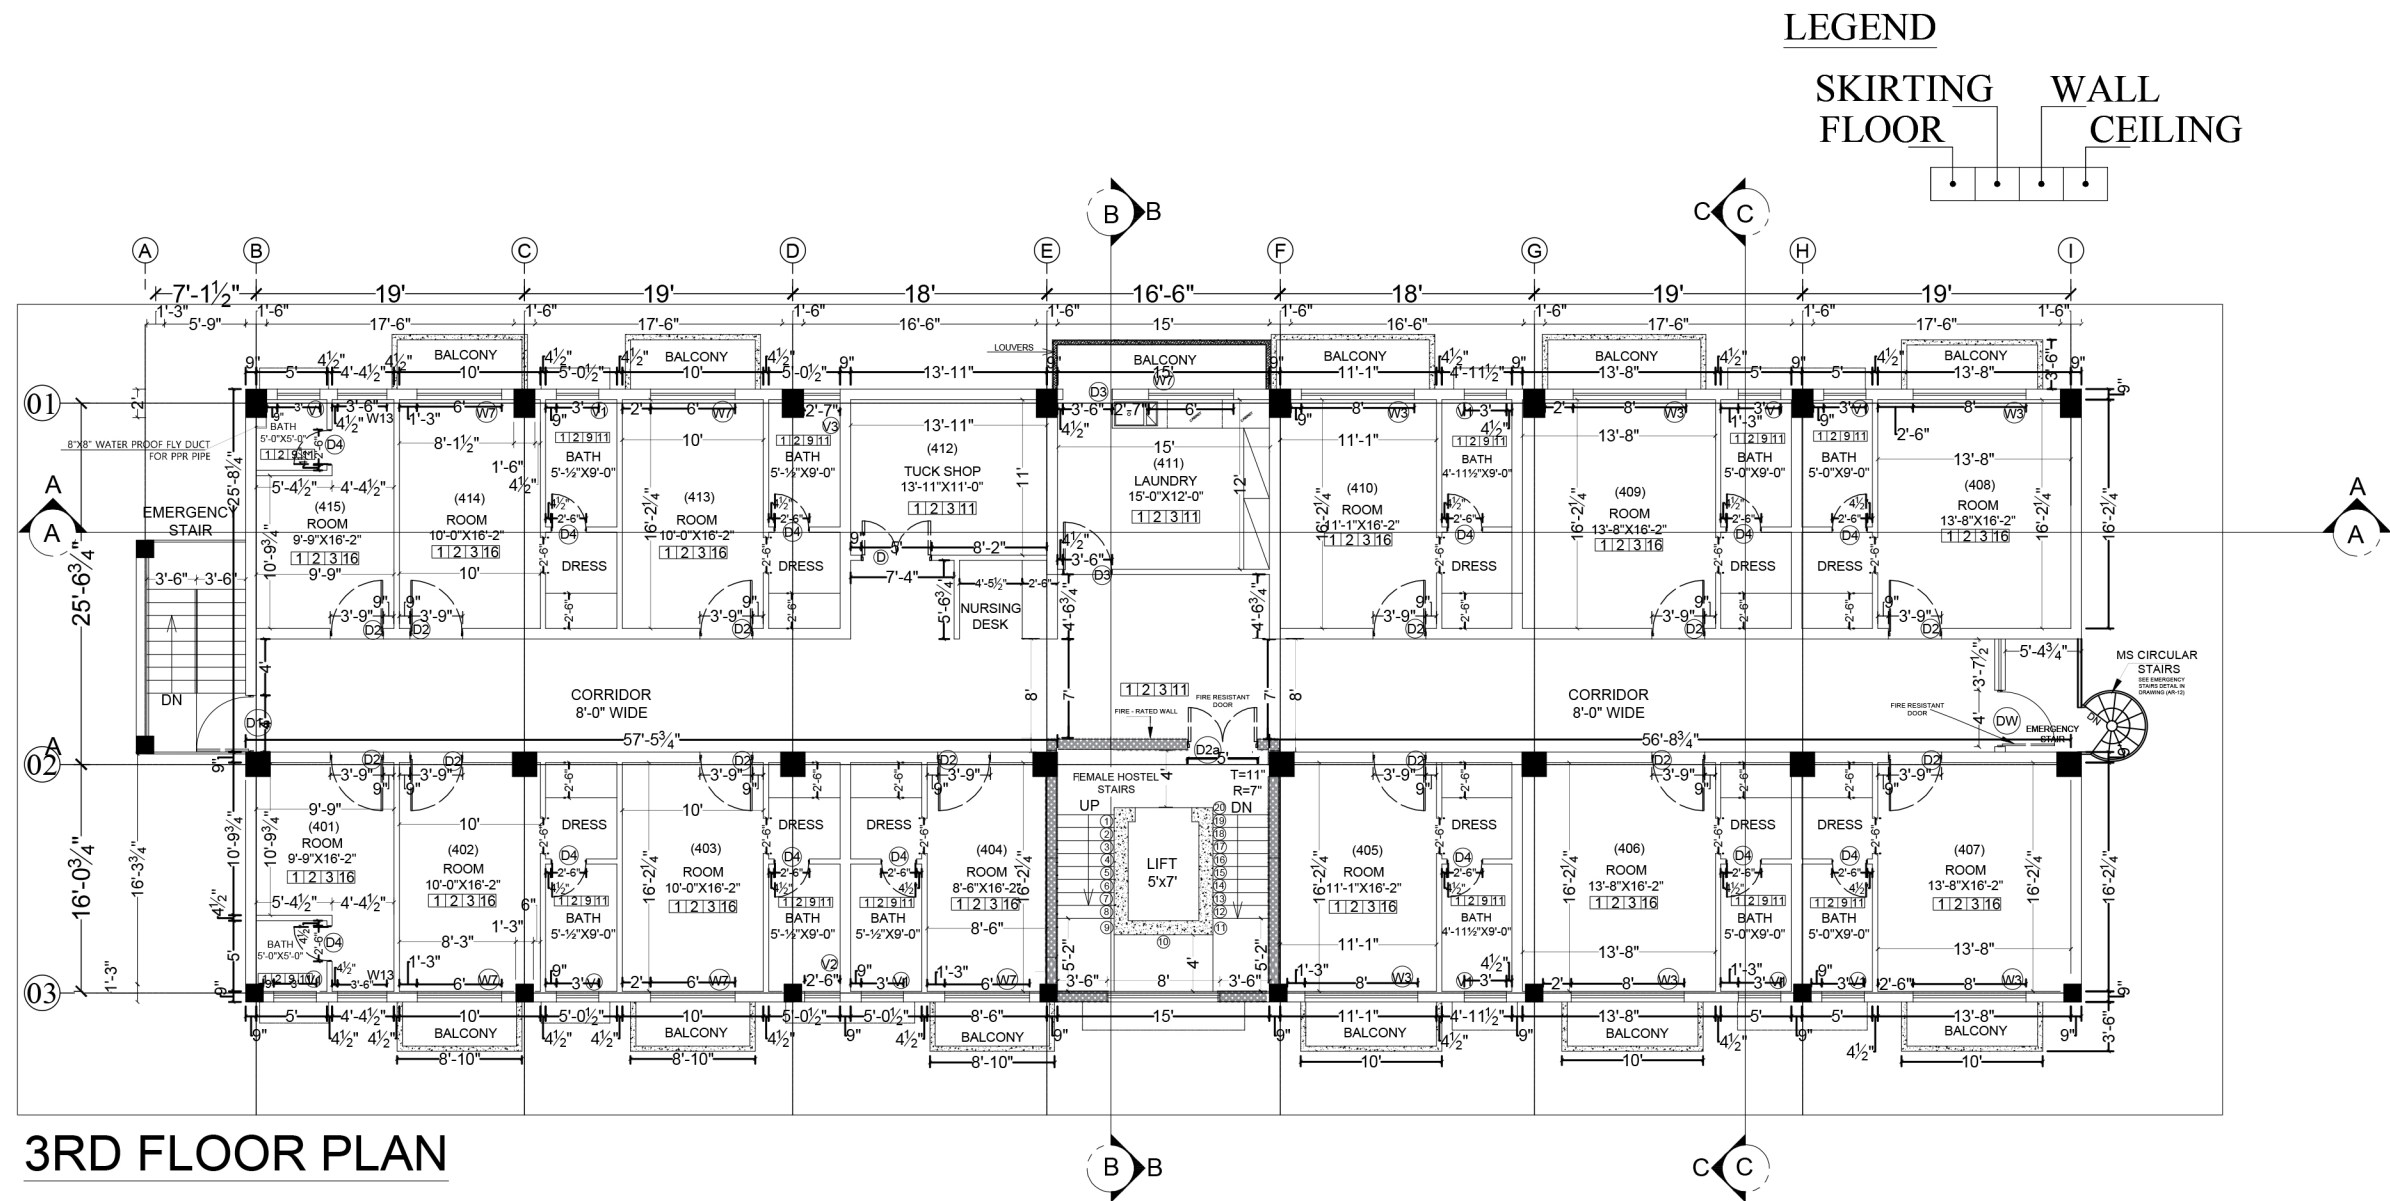

Project

ANTI-NARCOTIC FORCE ACADEMY
EXTENSION AND WOMEN'S HOSTEL


Client

UNITED NATIONS DEVELOPMENT PROGRAMME

Funding Agency

INTERNATIONAL NARCOTICS AND LAW
ENFORCEMENT AFFAIRS (INL)

Consultant

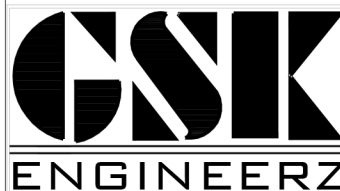


GSK ENGINEERZ

PLANNING - TESTING - DESIGNING & DEVELOPMENT
FLAT NO.205 & 206 2nd Floor, Afzal Tower Phase 3,
Main Intersection, Peshawar
Ph: +92-333-912-6118, +92-334-843-5340
E-mail: gsk.engineerz@gmail.com

SCALE :	ARCHITECT :	M.IQBAL
N.T.S	ARCHITECT :	
SHEET NO:	PREPARED BY :	GHANI REHMAN
AR - 06	PREPARED BY :	
DATE :	DRAWING TITLE:	3RD FLOOR PLAN
AUG - 2021	DRAWING TITLE:	

ARCHITECTURAL DRAWING



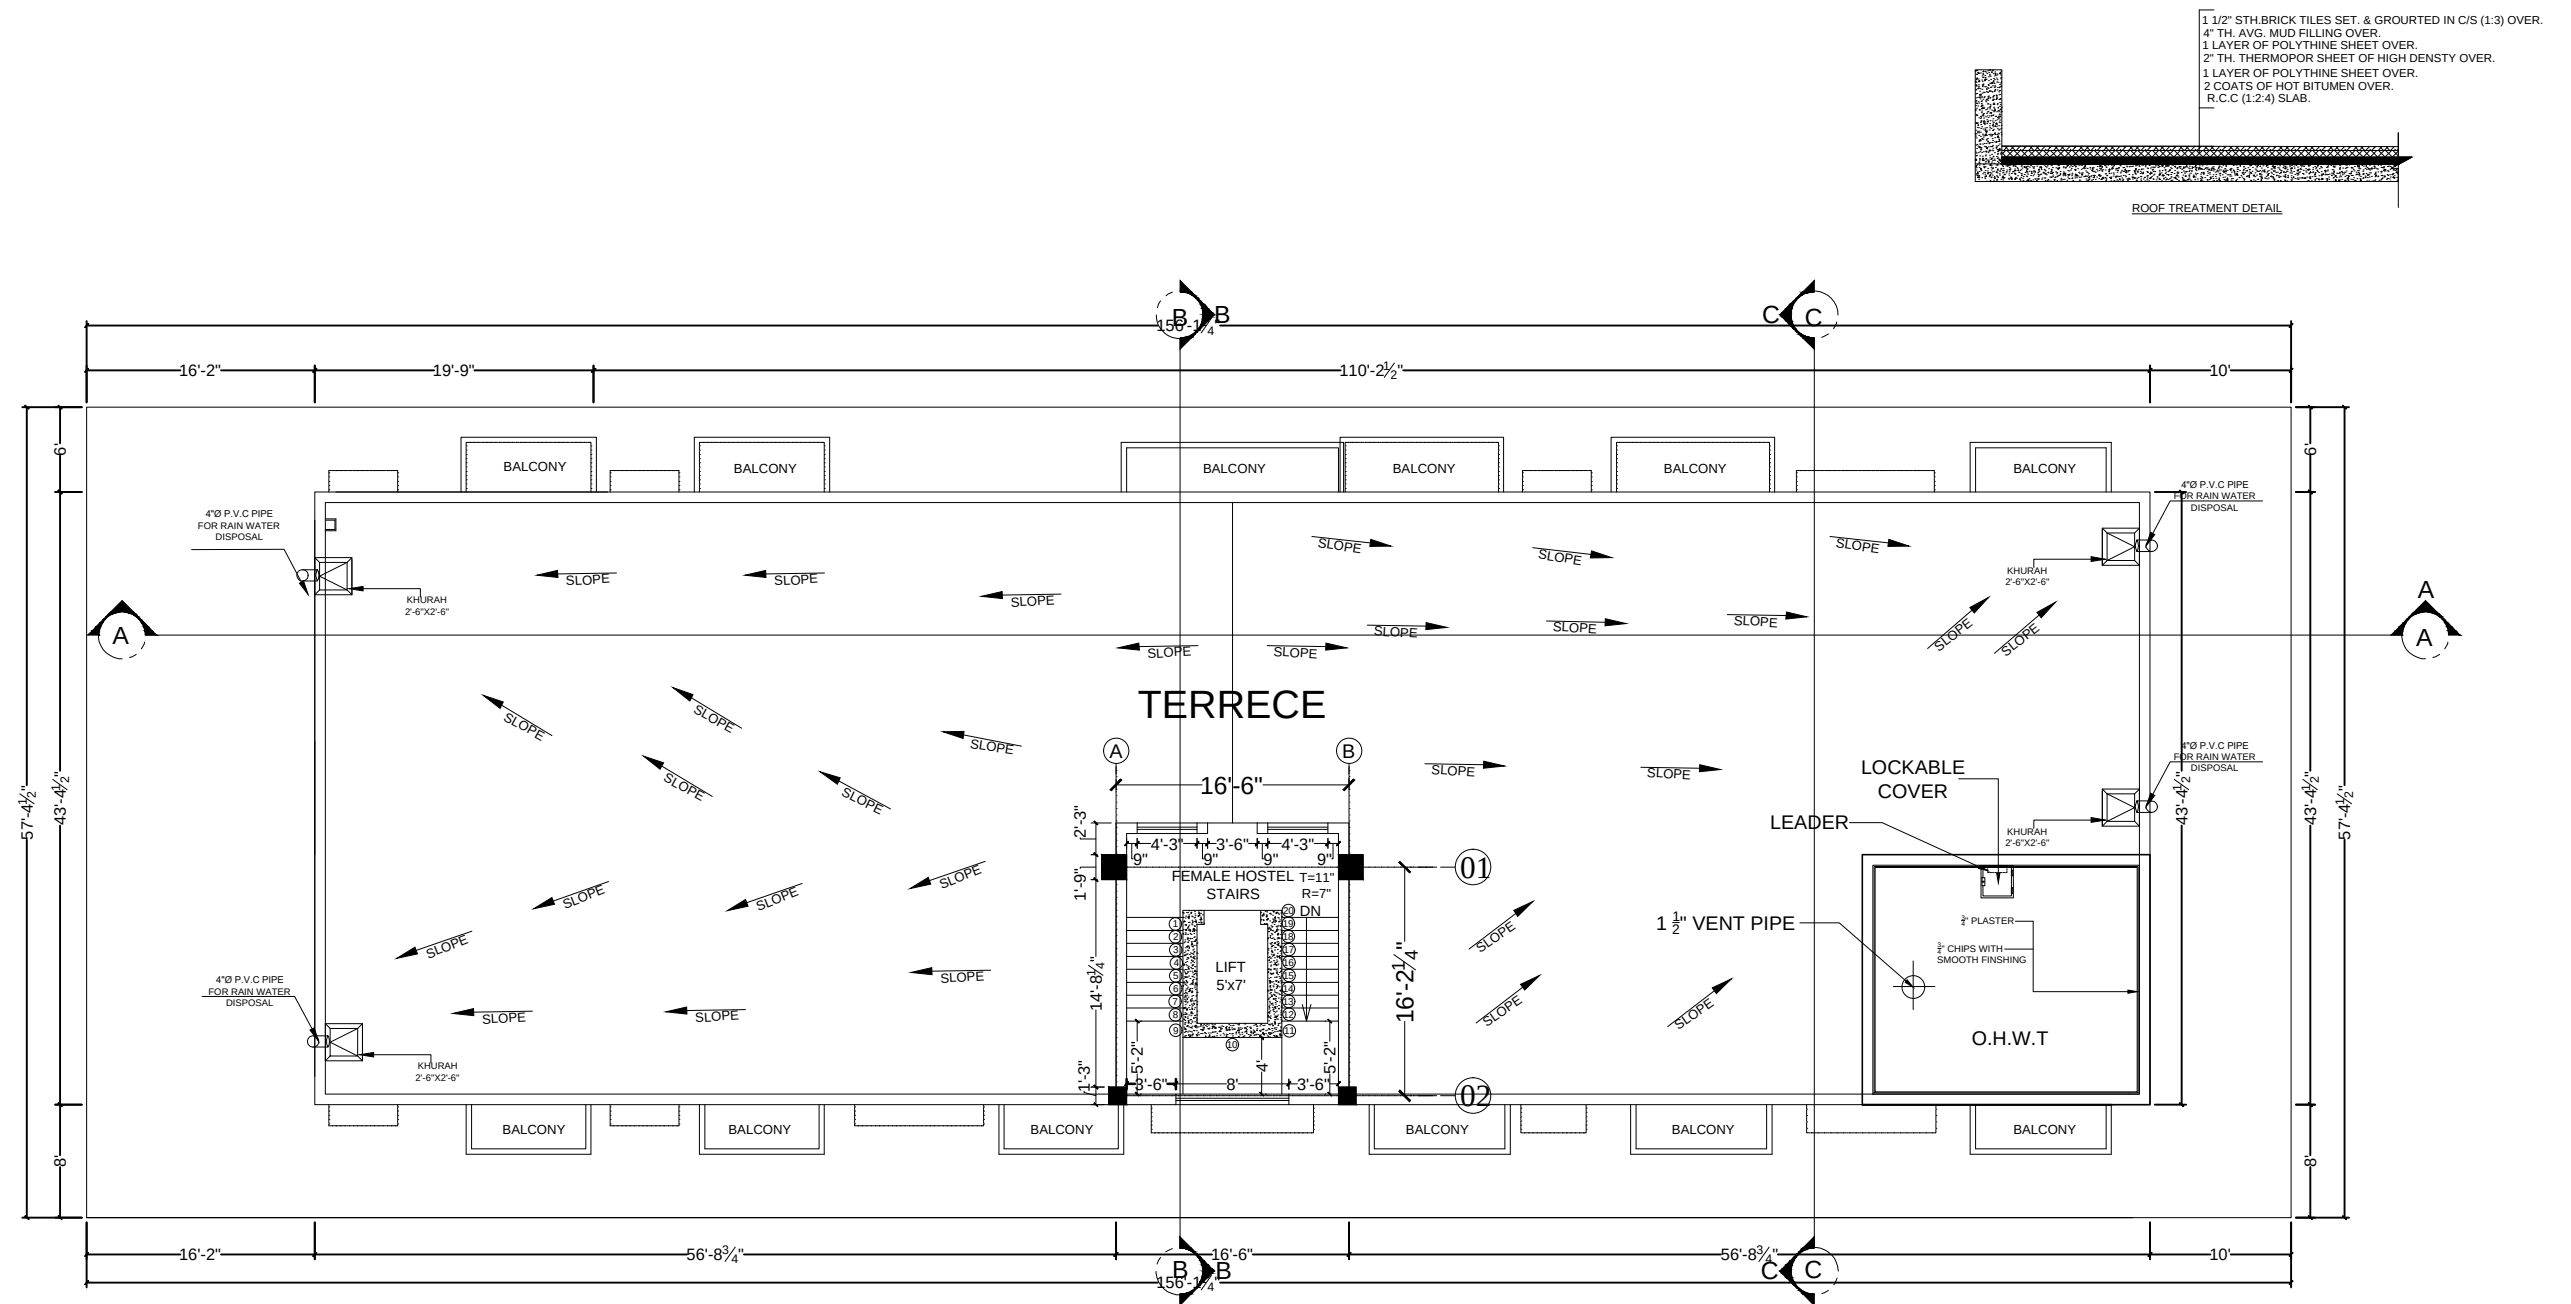

Project

ANTI-NARCOTIC FORCE ACADEMY
EXTENSION AND WOMEN'S HOSTEL


Client

UNITED NATIONS DEVELOPMENT PROGRAMME

Funding Agency

INTERNATIONAL NARCOTICS AND LAW
ENFORCEMENT AFFAIRS (INL)

Consultant

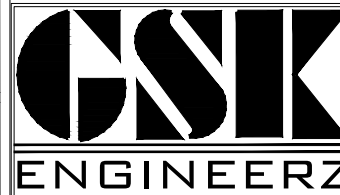

GSK ENGINEERZ

PLANNING - TESTING - DESIGNING & DEVELOPMENT
 FLAT NO 205 & 206 2nd Floor, Afzal Tower Phase 3,
 Main Intersection, Peshawar
 Ph: +92-333-912-6118, +92-334-843-5340
 E.mail: gsk.engineerz@gmail.com

SCALE :	N.T.S	ARCHITECT :	M.IQBAL
SHEET NO:	AR - 07	PREPARED BY :	GHANI REHMAN
DATE :	AUG - 2021	DRAWING TITLE:	ROOF TOP & ROOF TREATMENT
ARCHITECTURAL DRAWING			





FRONT ELEVATION

Project

ANTI-NARCOTIC FORCE ACADEMY
EXTENSION AND WOMEN'S HOSTEL


Client

UNITED NATIONS DEVELOPMENT PROGRAMME

Funding Agency

INTERNATIONAL NARCOTICS AND LAW
ENFORCEMENT AFFAIRS (INL)

Consultant

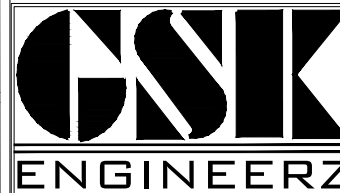

GSK ENGINEERZ

PLANNING - TESTING - DESIGNING & DEVELOPMENT
FLAT NO 205 & 206 2nd Floor, Afzal Tower Phase 3,
Main Intersection, Peshawar
Ph: +92-333-912-6118, +92-334-843-5340
E.mail: gsk.engineerz@gmail.com

SCALE : N.T.S	ARCHITECT : M.IQBAL	
SHEET NO : AR - 08	PREPARED BY : GHANI REHMAN	
DATE : AUG - 2021	DRAWING TITLE : FRONT ELEVATION	
ARCHITECTURAL DRAWING		





BACK SIDE ELEVATION

Project

ANTI-NARCOTIC FORCE ACADEMY
EXTENSION AND WOMEN'S HOSTEL


Client

UNITED NATIONS DEVELOPMENT PROGRAMME

Funding Agency

INTERNATIONAL NARCOTICS AND LAW
ENFORCEMENT AFFAIRS (INL)

Consultant

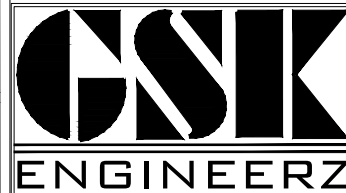

GSK ENGINEERZ

PLANNING - TESTING - DESIGNING & DEVELOPMENT
FLAT NO 205 & 206 2nd Floor, Afzal Tower Phase 3,
Main Intersection, Peshawar
Ph: +92-333-912-6118, +92-334-843-5340
E.mail: gsk.engineerz@gmail.com

SCALE : N.T.S	ARCHITECT : M.IQBAL	
SHEET NO : AR - 09	PREPARED BY : GHANI REHMAN	
DATE : AUG - 2021	DRAWING TITLE : BACK ELEVATION	
ARCHITECTURAL DRAWING		





= Project

ANTI-NARCOTIC FORCE ACADEMY
EXTENSION AND WOMEN'S HOSTEL


Client

UNITED NATIONS DEVELOPMENT PROGRAMME

Funding Agency

INTERNATIONAL NARCOTICS AND LAW ENFORCEMENT AFFAIRS (INL)


— *Consultant*

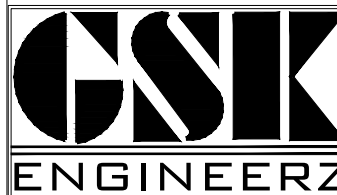


GSK ENGINEERZ


PLANNING - TESTING - DESIGNING & DEVELOPMENT
FLAT NO.205 & 206 2nd Floor, Afzal Tower Phase 3,
Main Intersection, Peshawar
Ph: +92-333-912-6118, +92-334-843-5340
E.mail: gsk.engineerz@gmail.com

SCALE : N.T.S	ARCHITECT : M.IQBAL	
SHEET NO : AR - 10	PREPARED BY : GHANI REHMAN	
DATE : AUG - 2021	DRAWING TITLE:	SECTION A - A
ARCHITECTURAL DRAWING		

 

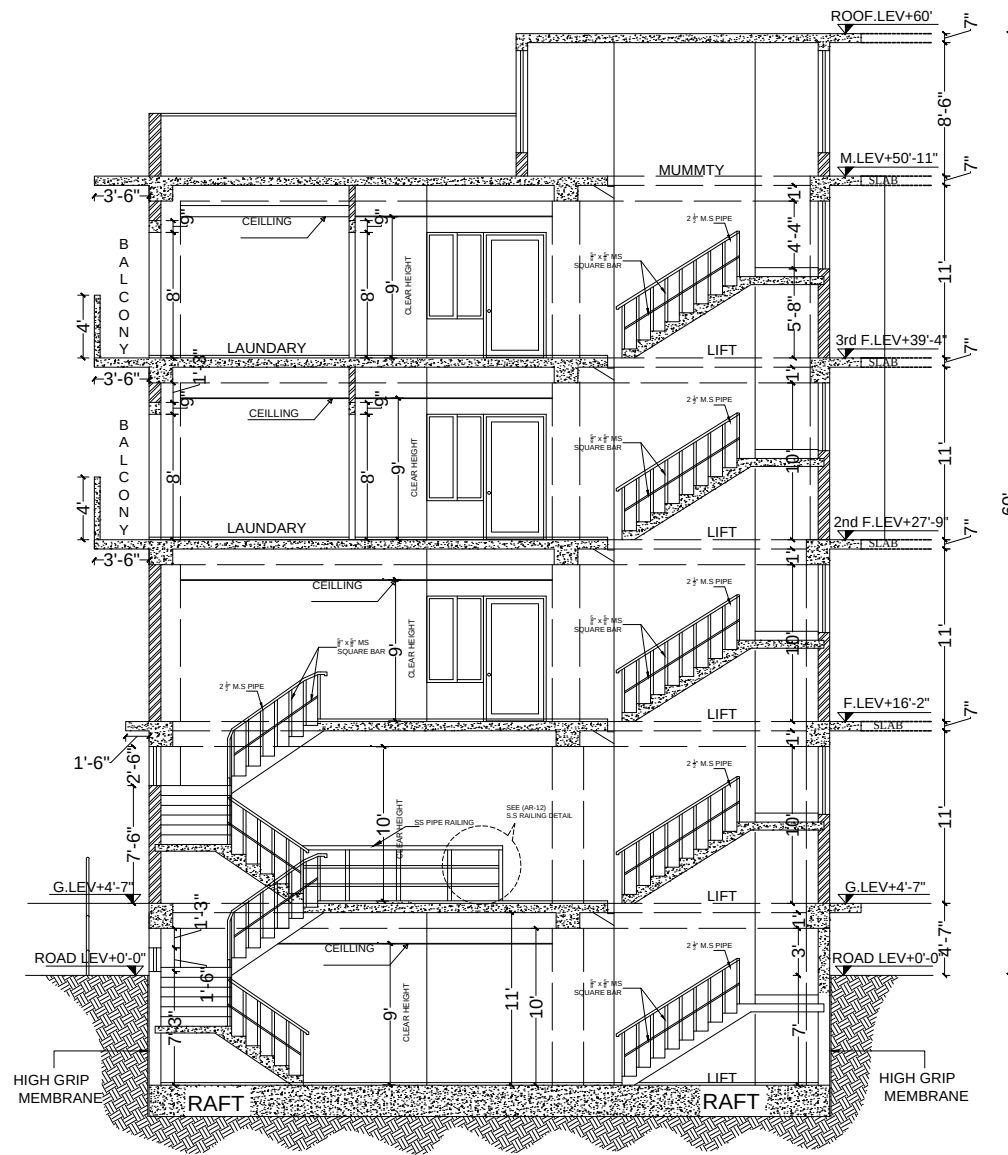

SECTION AT B-B

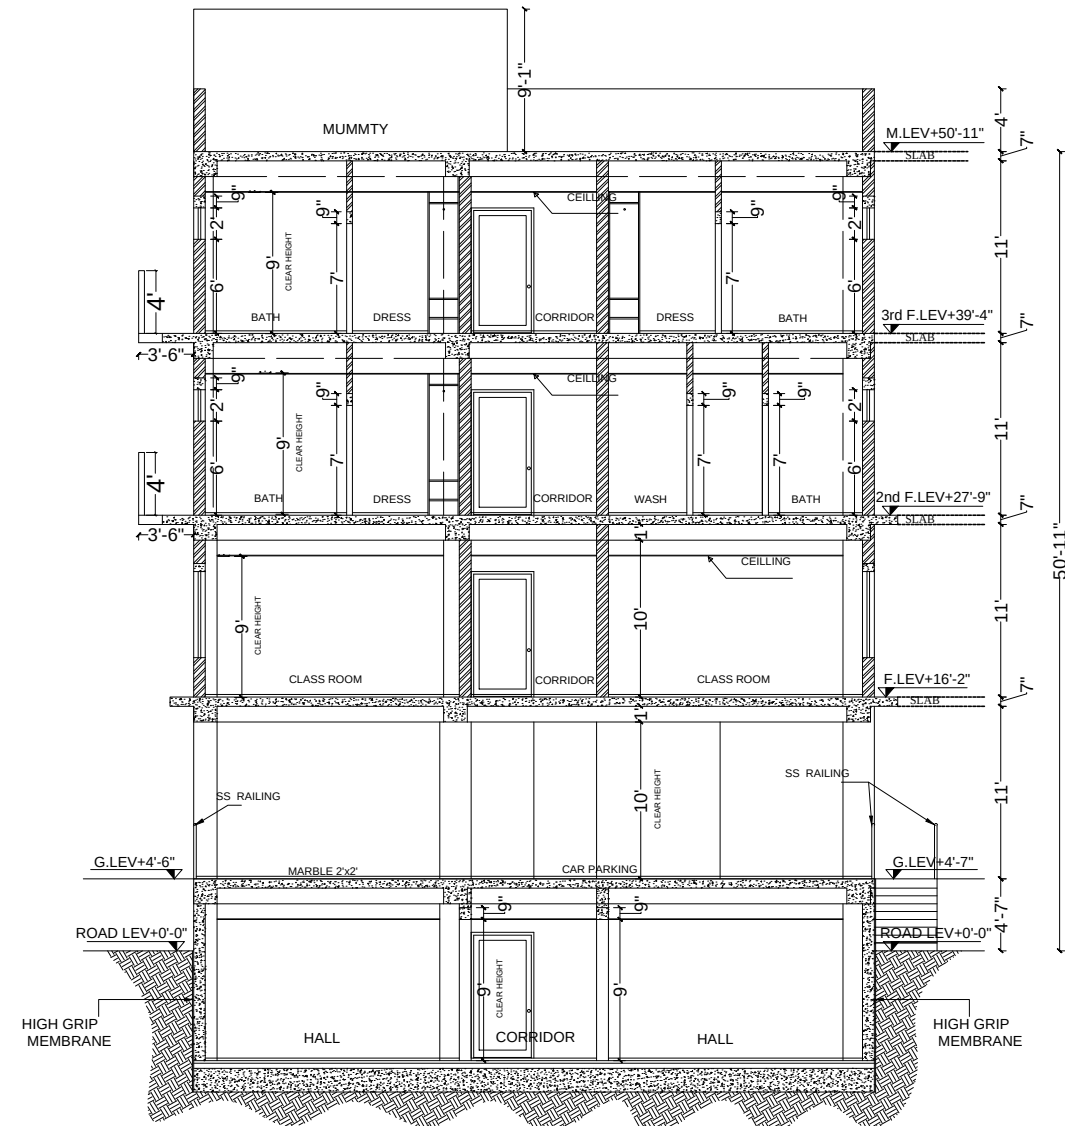

SECTION AT C-C

Project

ANTI-NARCOTIC FORCE ACADEMY
EXTENSION AND WOMEN'S HOSTEL


Client

UNITED NATIONS DEVELOPMENT PROGRAMME

Funding Agency

INTERNATIONAL NARCOTICS AND LAW
ENFORCEMENT AFFAIRS (INL)

Consultant

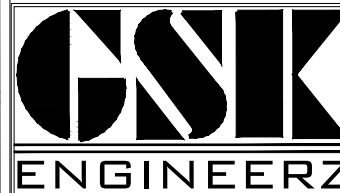


GSK ENGINEERZ

PLANNING - TESTING - DESIGNING & DEVELOPMENT
FLAT NO 205 & 206 2nd Floor, Afzal Tower Phase 3,
Main Intersection, Peshawar
Ph: +92-333-912-6118, +92-334-843-5340
E.mail: gsk.engineerz@gmail.com


SCALE :	N.T.S	ARCHITECT :	M.IQBAL
SHEET NO :	AR - II	PREPARED BY :	GHANI REHMAN
DATE :	AUG - 2021	DRAWING TITLE :	SECTION B & C
ARCHITECTURAL DRAWING			




EMERGENCY STAIRS DETAIL

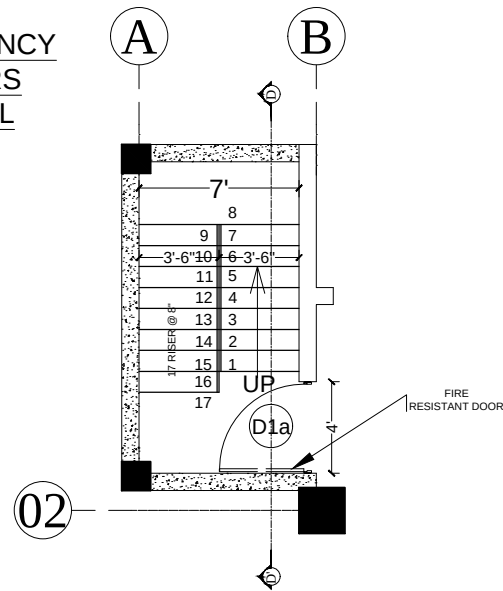


BASEMENT TO GROUND FLOOR STAIRS

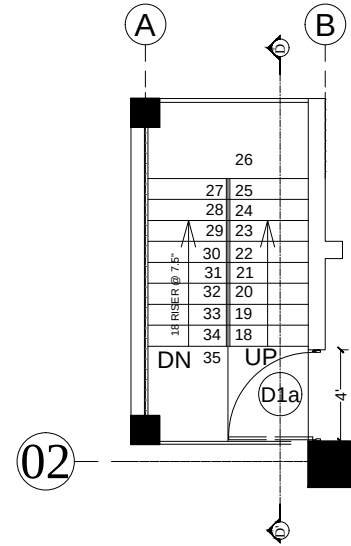

1ST TO 3RD FLOOR STAIRS


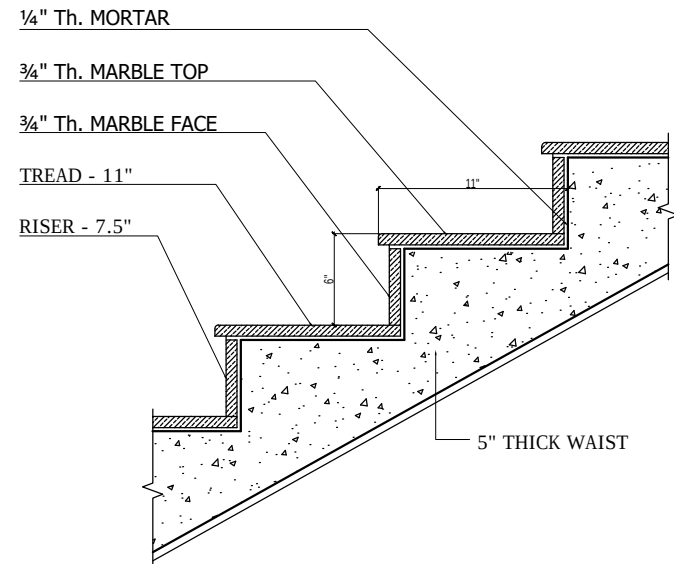


TYPICAL STAIR DETAIL-(A)

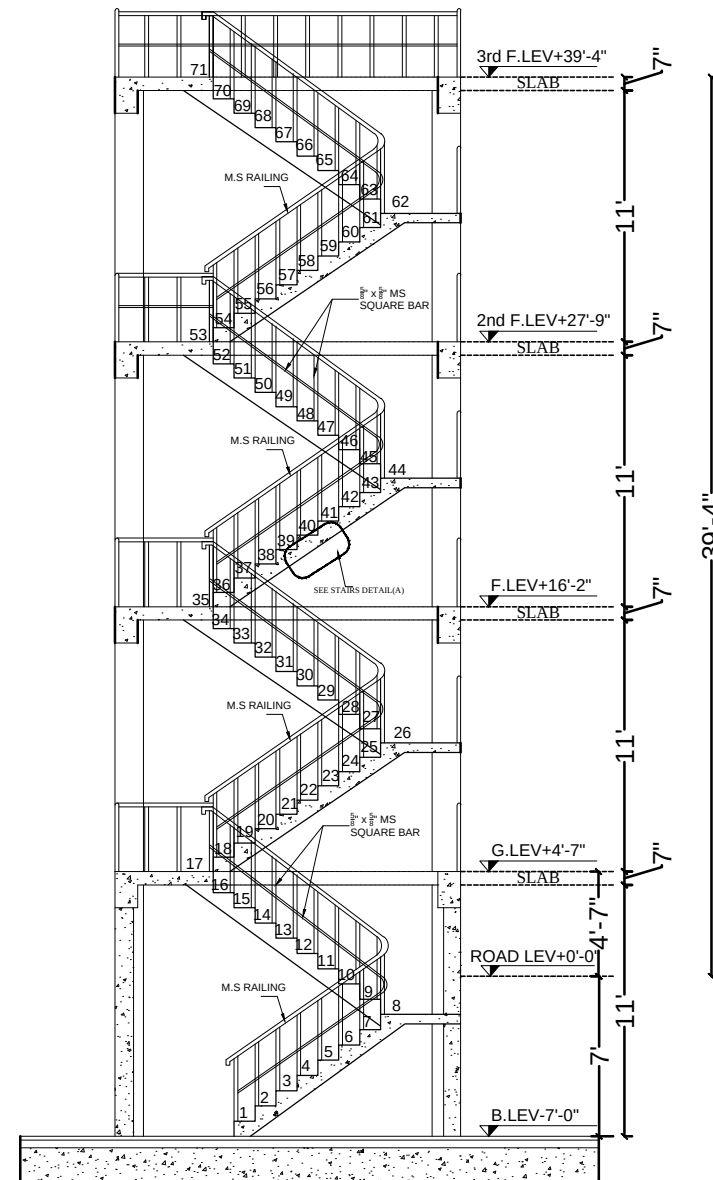

STAIR SECTION

EMERGENCY CIRCULAR STAIRS DETAIL

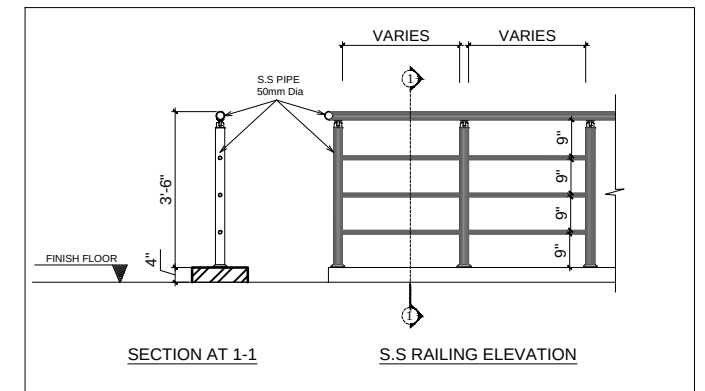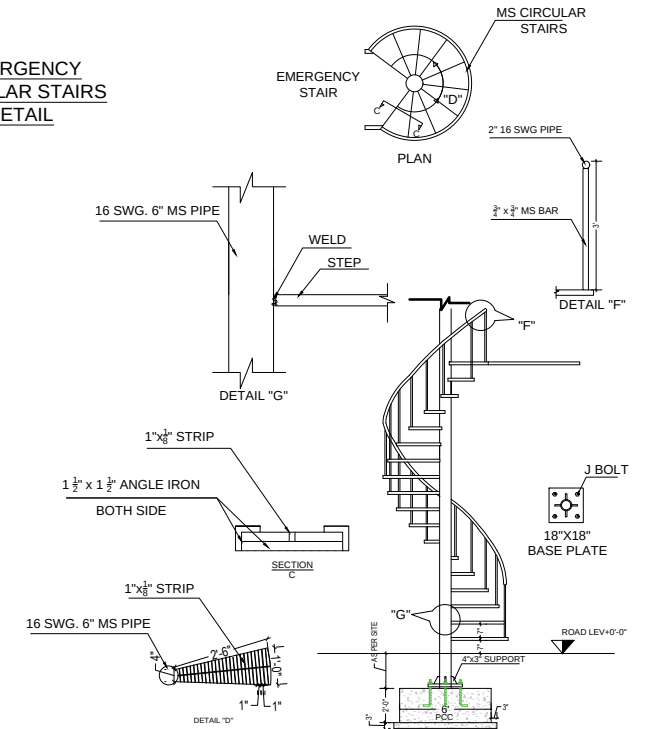

S.S RAILING DETAIL


Project

ANTI-NARCOTIC FORCE ACADEMY
EXTENSION AND WOMEN'S HOSTEL

Client

UNITED NATIONS DEVELOPMENT PROGRAMME
Funding Agency
INTERNATIONAL NARCOTICS AND LAW
ENFORCEMENT AFFAIRS (INL)


Consultant

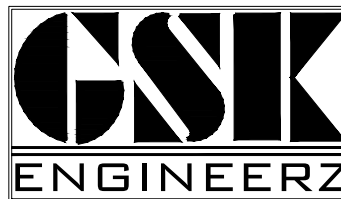


GSK ENGINEERZ
PLANNING - TESTING - DESIGNING & DEVELOPMENT
FLAT NO.205 & 206 2nd Floor, Afzal Tower Phase 3,
Main Intersection, Peshawar
Ph: +92-333-912-6118, +92-334-843-5340
E.mail: gsk.engineerz@gmail.com

SCALE : N.T.S	ARCHITECT : M.IQBAL	
SHEET NO: AR - 12	PREPARED BY : GHANI REHMAN	
DATE : AUG - 2021	DRAWING TITLE: EMERGENCY STAIR DETAILS	
ARCHITECTURAL DRAWING		

RAMP DETAIL

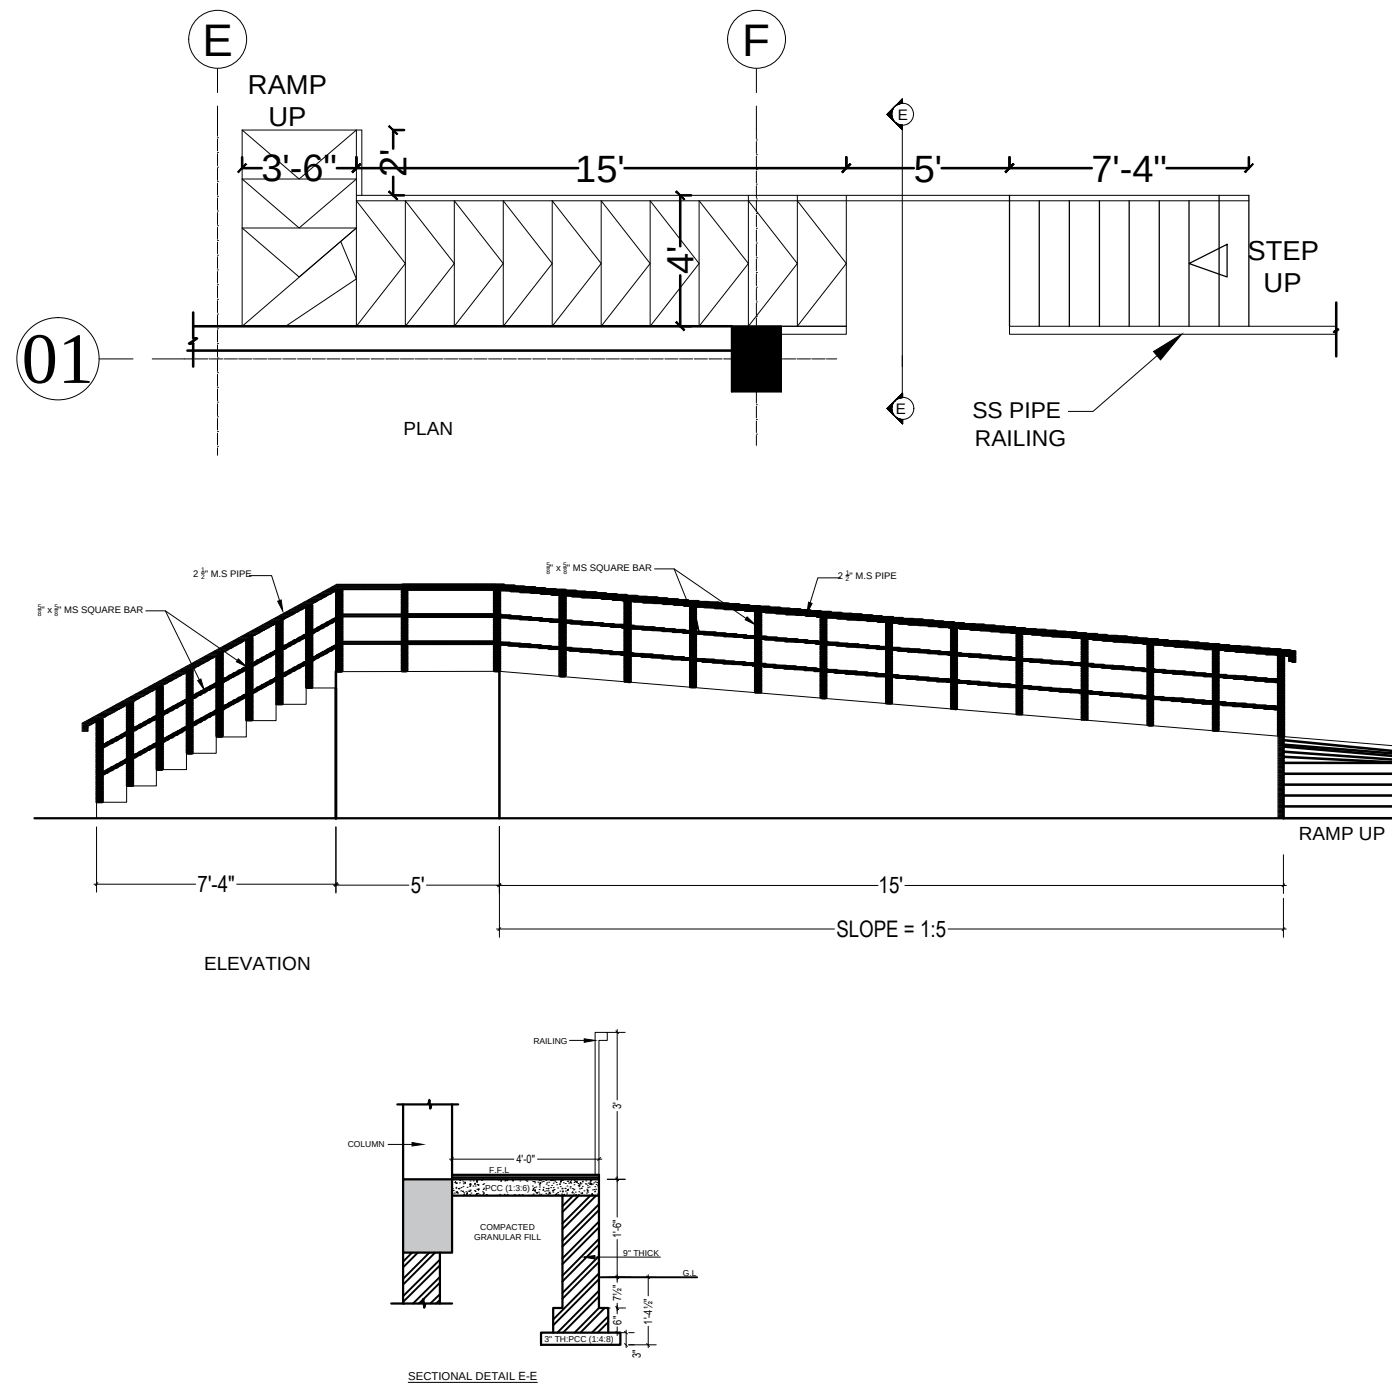

GARAGE DOOR DETAIL AT ROAD CHECK POINT HALL

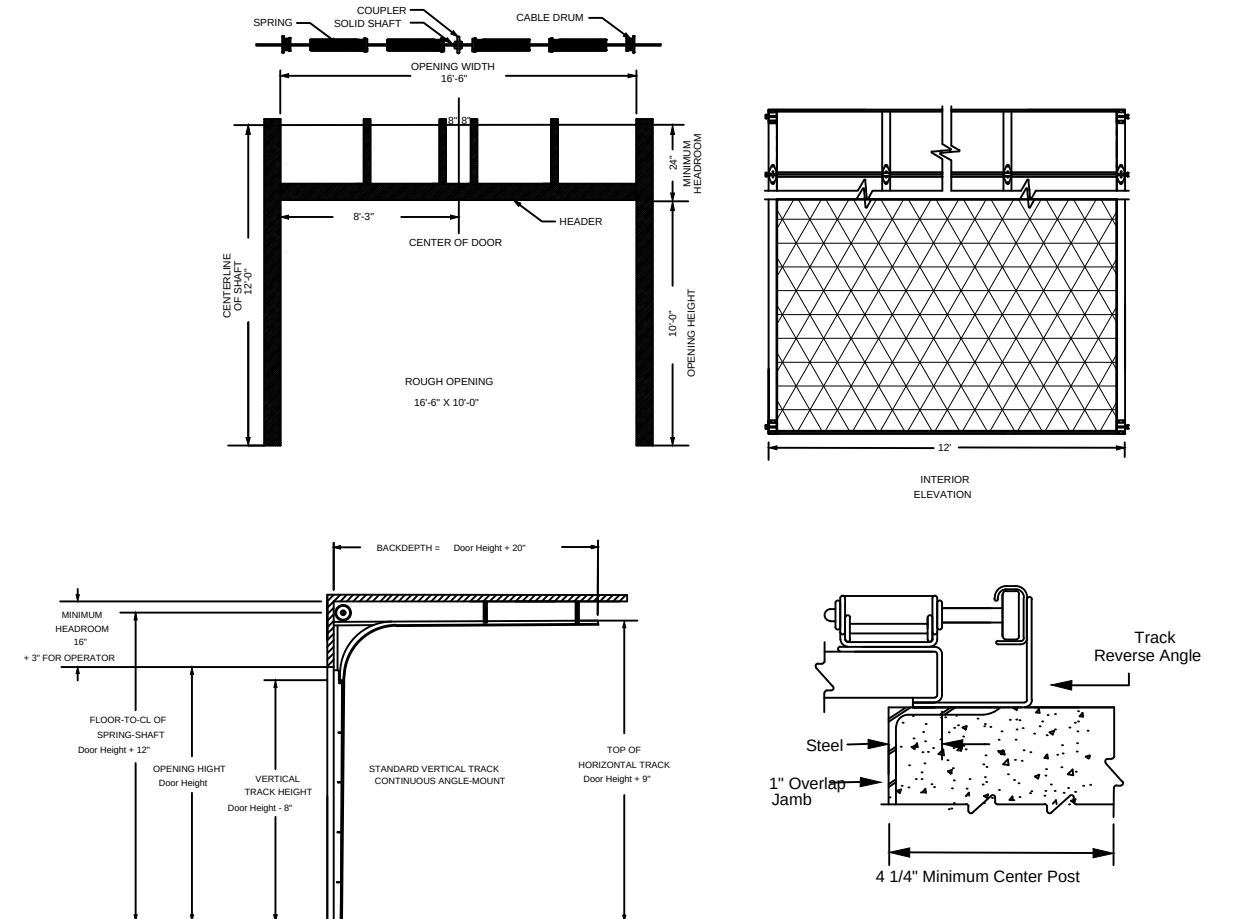

Project

ANTI-NARCOTIC FORCE ACADEMY
EXTENSION AND WOMEN'S HOSTEL

Client

UNITED NATIONS DEVELOPMENT PROGRAMME

Funding Agency

INTERNATIONAL NARCOTICS AND LAW
ENFORCEMENT AFFAIRS (INL)

Consultant

GSK ENGINEERZ

PLANNING - TESTING - DESIGNING & DEVELOPMENT
FLAT NO.205 & 206 2nd Floor, Afzal Tower Phase 3,
Main Intersection, Peshawar
Ph: +92-333-912-6118, +92-334-843-5340
E-mail: gsk.engineerz@gmail.com

SCALE : N.T.S	ARCHITECT : M.IQBAL	
SHEET NO: AR - 13	PREPARED BY : GHANI REHMAN	
DATE : AUG - 2021	DRAWING TITLE: RAMP & GARAGE DOOR DETAILS	
ARCHITECTURAL DRAWING		












Architectural drawing of a Female Lavatory showing floor and wall tile specifications.

The main plan view shows a rectangular room with various fixtures and dimensions:

- 12'x12" MATT TILE (Wall)
- 16'-2" (Dimension)
- 10' (Dimension)
- 10'X16'-2" FEMALE LAVATORY
- DISABLED TOILET
- S.S. PIPE
- S.S. HANDRAIL / GRAB BAR
- W.C.
- MUSLIM SHOWER
- SHOWER
- TISSUE PAPER HOLDER
- VANITY
- 01 (Callout)
- B (Callout)

A circular inset shows a 12'X12" CERAMIC FLOOR & WALL TILE with a grid pattern and dimensions: 2mm, 1', 2mm, 1'.

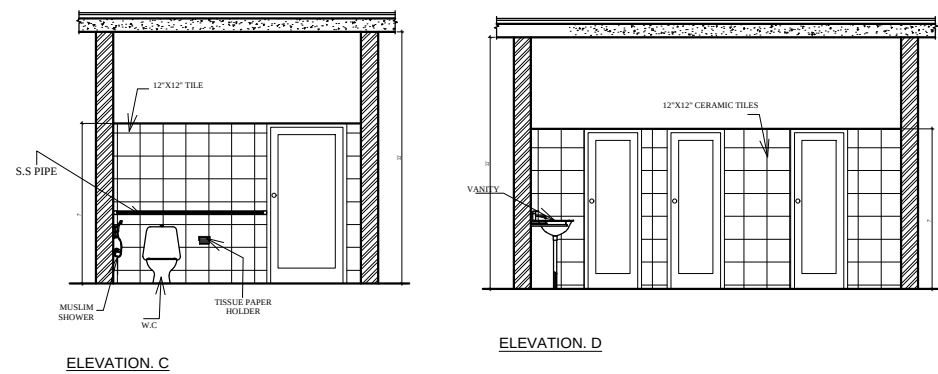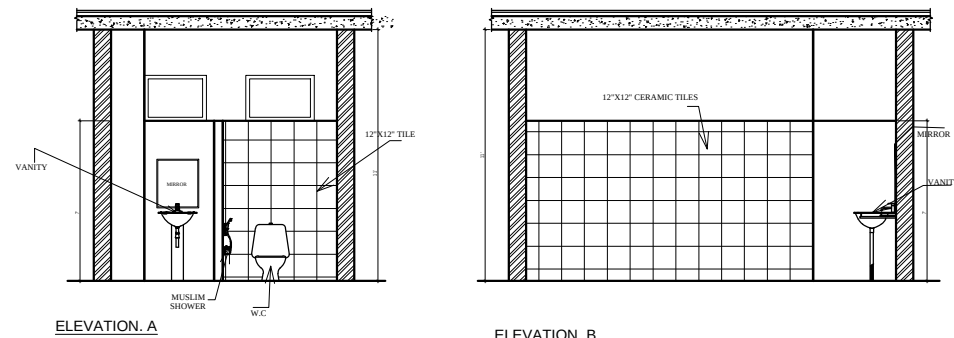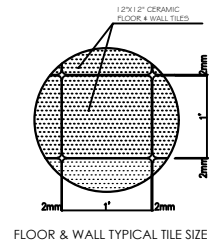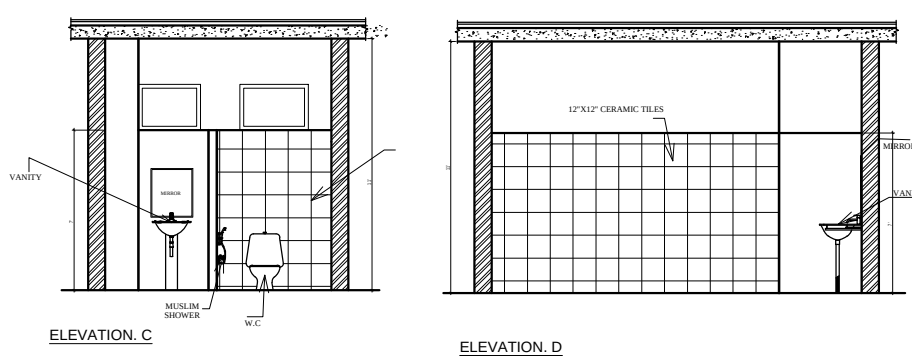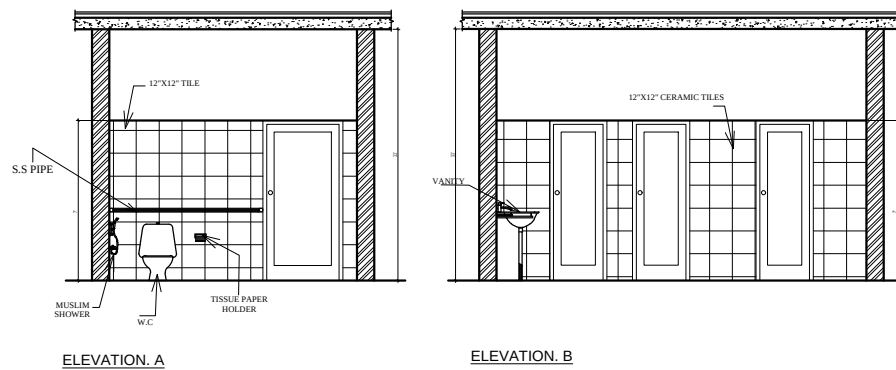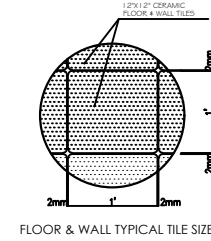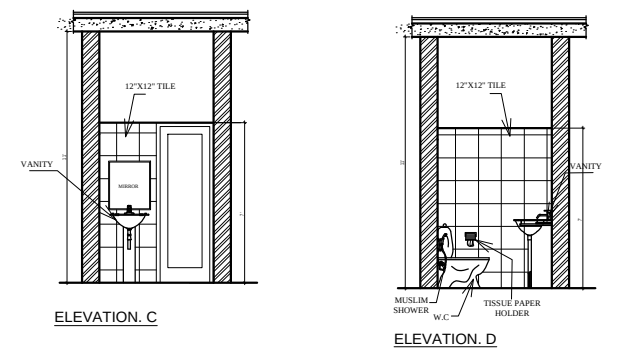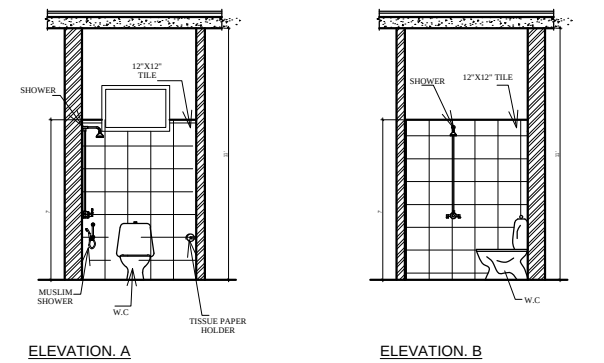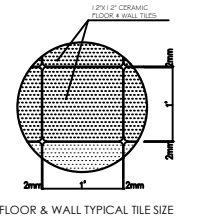[illegible][illegible]

<i>Client</i> UNITED NATIONS DEVELOPMENT PROGRAMME <i>Funding Agency</i> INTERNATIONAL NARCOTICS AND LAW ENFORCEMENT AFFAIRS (INL)	
--	--

SCALE : N.T.S	ARCHITECT :	M.IQBAL
SHEET NO: AR -14	PREPARED BY :	GHANI REHMAN
DATE : AUG -2021	DRAWING TITLE:	TOILET DETAILS

ARCHITECTURAL DRAWING



WINDOW SCHEDULE :

S/NO	TYPE	SIZE	S/LEVEL
1	W	6'-0"X6'-6"	+1'-6"
2	W1	10'-0"X5'-6"	+2'-6"
3	W2	8'-6"X5'-6"	+2'-6"
4	W3	8'-0"X5'-6"	+2'-6"
5	W4	7'-7½"X5'-6"	+2'-6"
6	W5	7'-3"X5'-6"	+2'-6"
7	W6	7'-0"X5'-6"	+2'-6"
8	W7	6'-0"X5'-6"	+2'-6"
9	W8	5'-3"X5'-6"	+2'-6"
10	W9	5'-0"X5'-6"	+2'-6"
11	W10	8'-0"X4'-0"	+4'-0"
12	W11	6'-0"X4'-0"	+4'-0"
13	W12	3'-9"X4'-0"	+4'-0"
14	W13	3'-6"X5'-6"	+2'-6"
15	HLW	8'-0"X1'-6"	+7'-6"
15	DW	(4'X8')X (3'-7½"X5'-6")	+0'-0" +2'-6"
16	V	3'-6"X2'-0"	+6'-0"
17	V1	3'-0"X2'-0"	+6'-0"
18	V2	2'-6"X2'-0"	+6'-0"




NOTE: LAMINATED GLASS TO BE USED IN WINDOWS, FOR SPECIFICATION CHECK BOQ

ALUMINIUM FRAME TO INCLUDE WIRE MESH / INSECT SCREEN

ALL WINDOWS AND DOORS WILL BE CAULKED FROM INTERIOR AND EXTERIOR

DOOR SCHEDULE :

S/NO	TYPE	SIZE	S/LEVEL	FRAME	MATERIAL	FINISHING
1	D	5'-0"X8'-0"	±0.0	16 SWG.MS	WOODEN	ENAMEL PAINT
2	D1	4'-0"X8'-0"	±0.0	16 SWG.MS	WOODEN	ENAMEL PAINT
3	D1a	4'-0"X8'-0"	±0.0	16 SWG.MS	16 SWG.MS	ENAMEL PAINT
4	D2	3'-9"X7'-0"	±0.0	16 SWG.MS	WOODEN	ENAMEL PAINT
5	D3	3'-6"X7'-0"	±0.0	16 SWG.MS	WOODEN	ENAMEL PAINT
6	D4	2'-6"X7'-0"	+4".0	PVC	PVC	APPROVED COLOR

 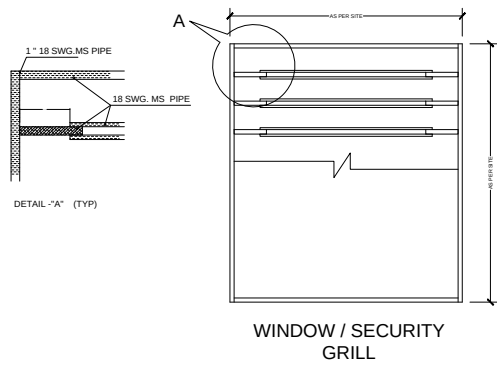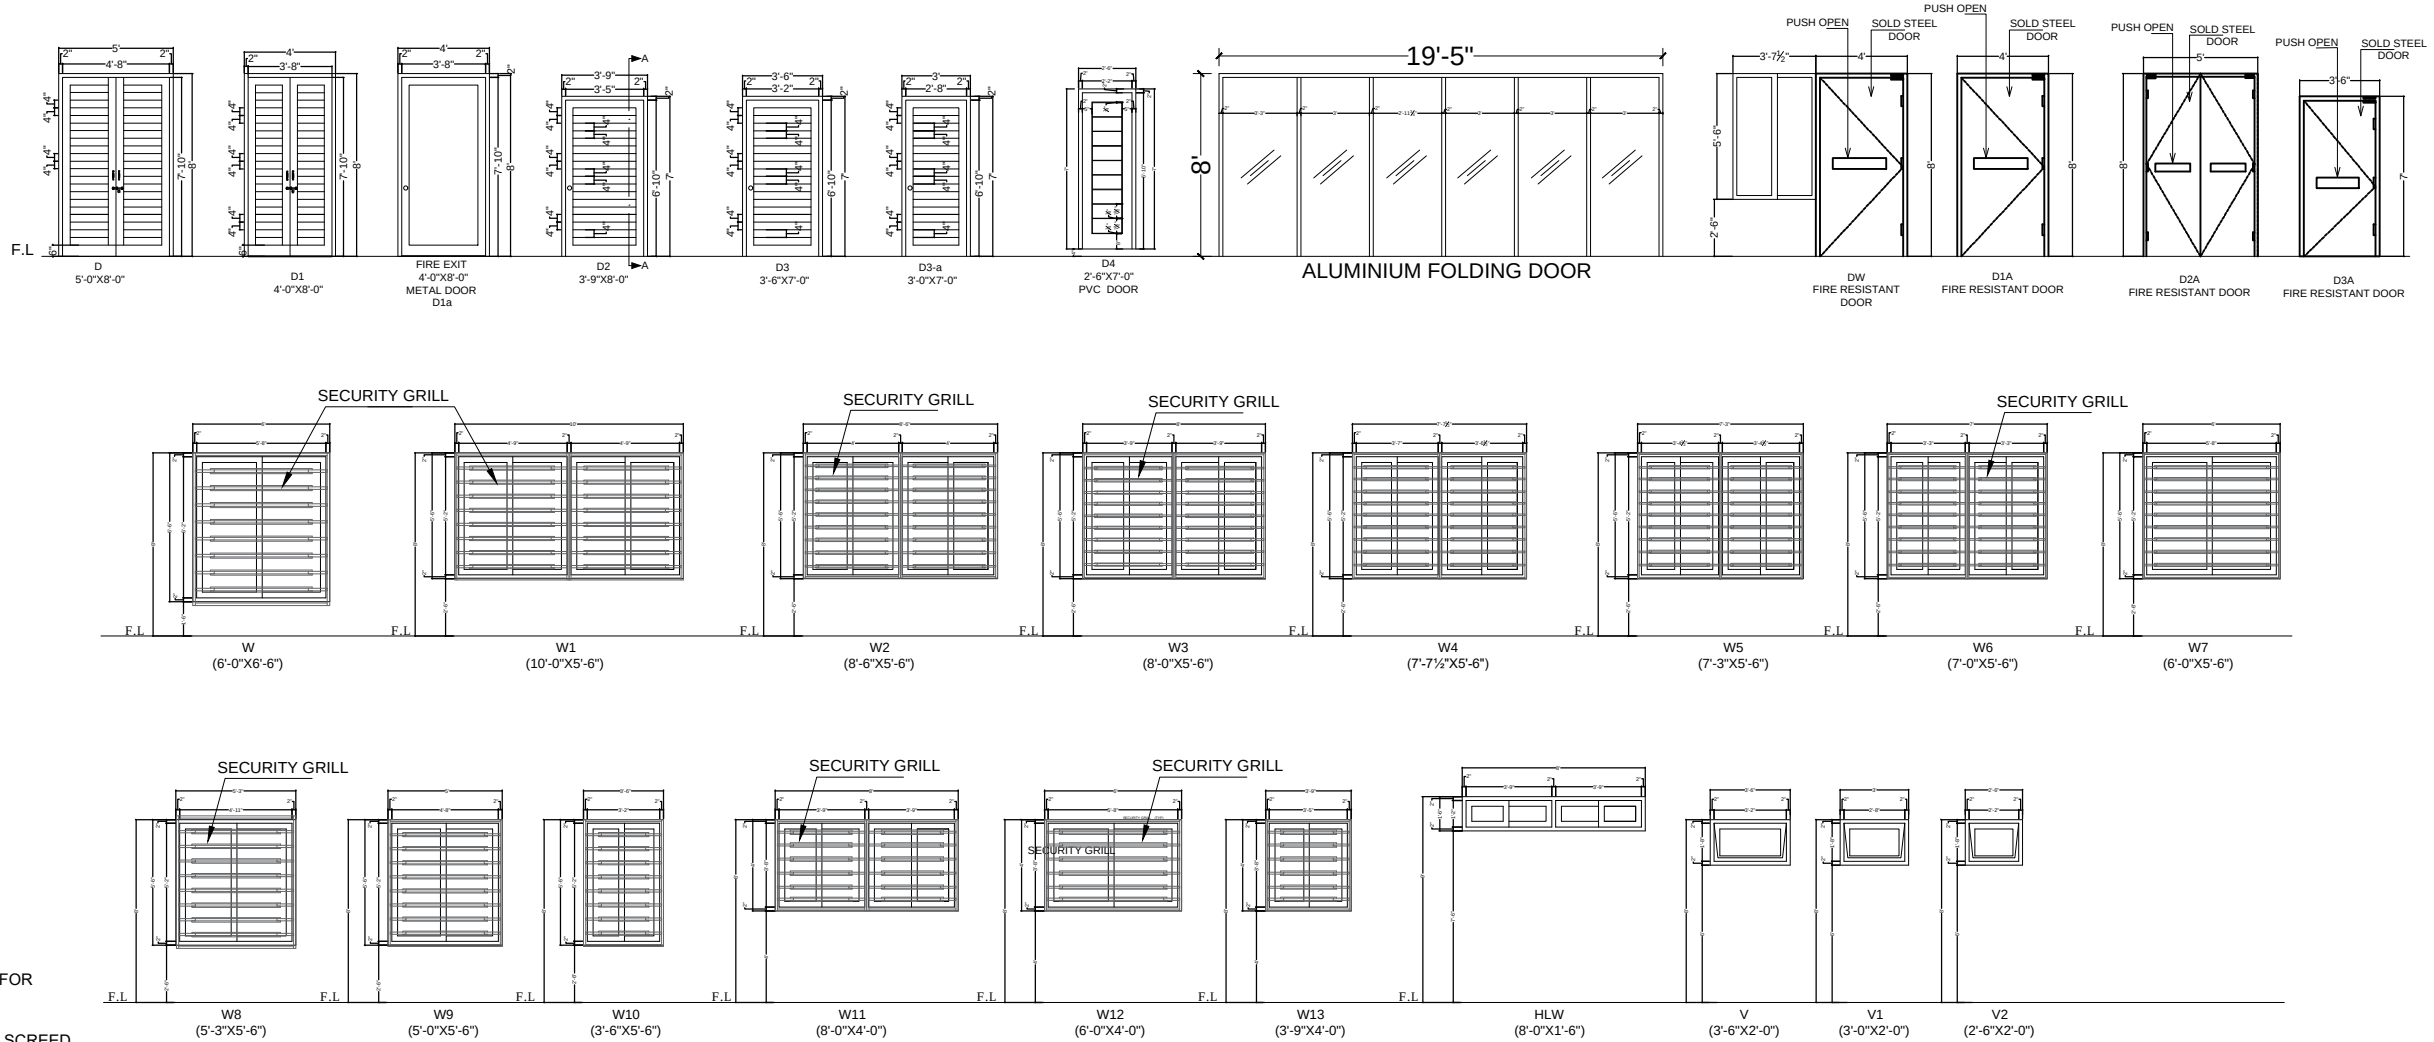

Project

ANTI-NARCOTIC FORCE ACADEMY
EXTENSION AND WOMEN'S HOSTEL


Client

UNITED NATIONS DEVELOPMENT PROGRAMME

Funding Agency

INTERNATIONAL NARCOTICS AND LAW
ENFORCEMENT AFFAIRS (INL)


Consultant





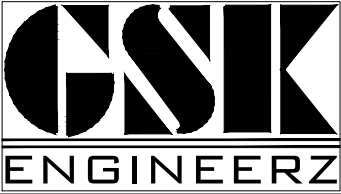


GSK ENGINEERZ

PLANNING - TESTING - DESIGNING & DEVELOPMENT
FLAT NO 205 & 206 2nd Floor, Afzal Tower Phase 3,
Main Intersection, Peshawar
Ph: +92-333-912-6118, +92-334-843-5340
E.mail: gsk.engineerz@gmail.com

SCALE :	N.T.S	ARCHITECT :	M.IQBAL
SHEET NO:	AR - 15	PREPARED BY :	GHANI REHMAN
DATE :	AUG - 2021	DRAWING TITLE:	DOOR, WINDOW AND WINDOW GRILL DETAIL
ARCHITECTURAL DRAWING			

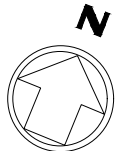

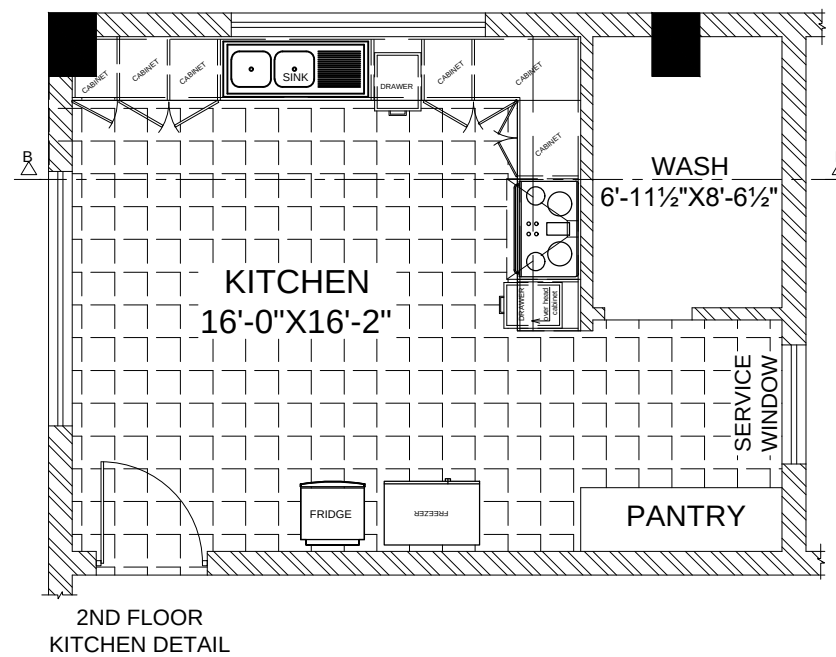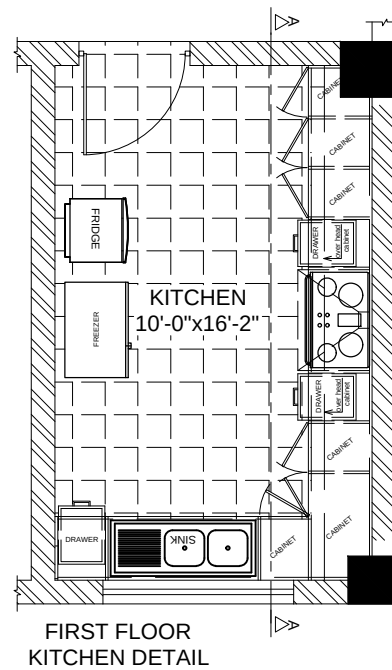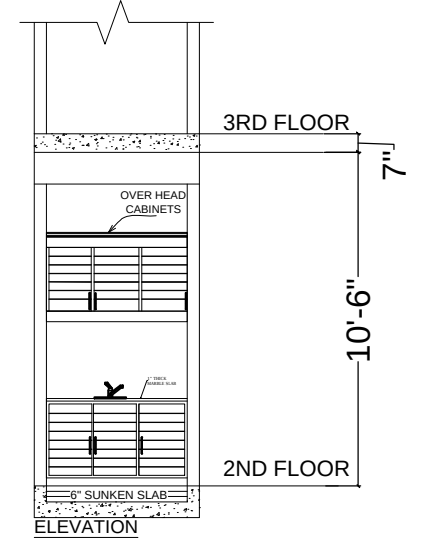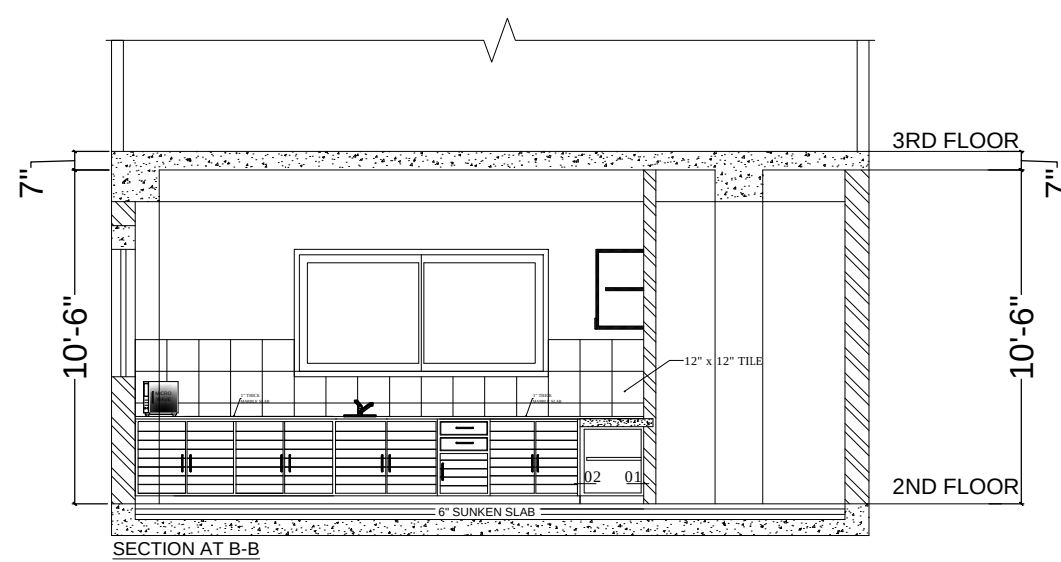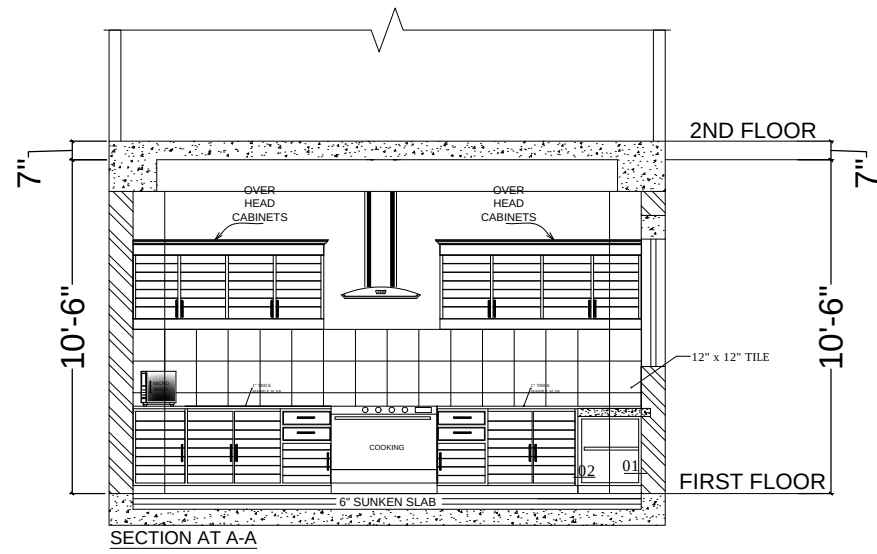

Project

ANTI-NARCOTIC FORCE ACADEMY
EXTENSION AND WOMEN'S HOSTEL


Client

UNITED NATIONS DEVELOPMENT PROGRAMME

Funding Agency

INTERNATIONAL NARCOTICS AND LAW
ENFORCEMENT AFFAIRS (INL)










Consultant

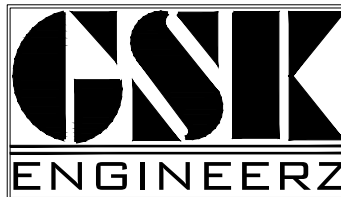

GSK ENGINEERZ
PLANNING - TESTING - DESIGNING & DEVELOPMENT
FLAT NO.205 & 206 2nd Floor, Afzal Tower Phase 3,
Main Intersection, Peshawar
Ph: +92-333-912-6118, +92-334-843-5340
E-mail: gsk.engineerz@gmail.com

SCALE : N.T.S	ARCHITECT : M.IQBAL	
SHEET NO : AR - 16	PREPARED BY : GHANI REHMAN	
DATE : AUG - 2021	DRAWING TITLE : KITCHEN DETAIL	
ARCHITECTURAL DRAWING		



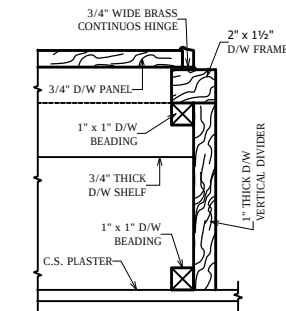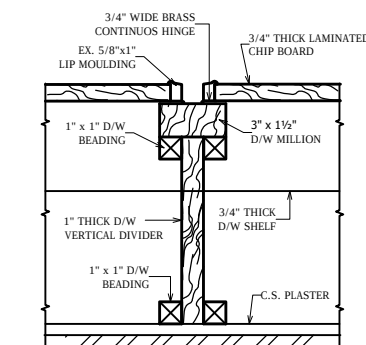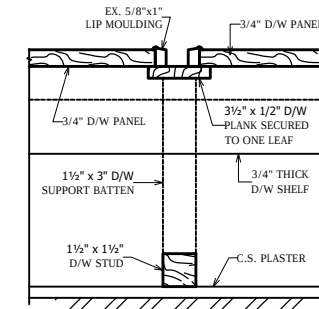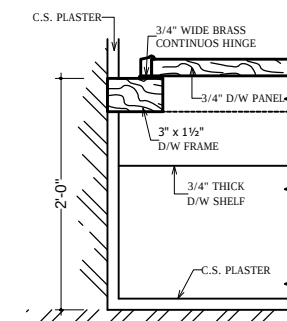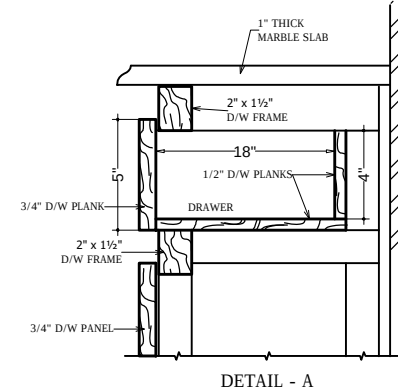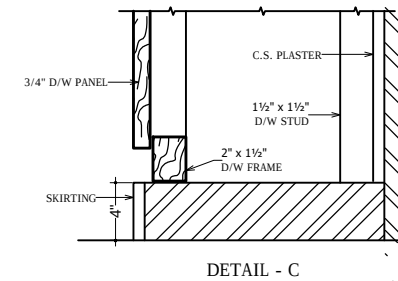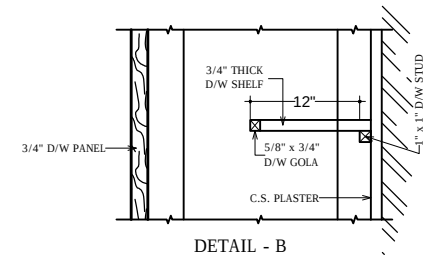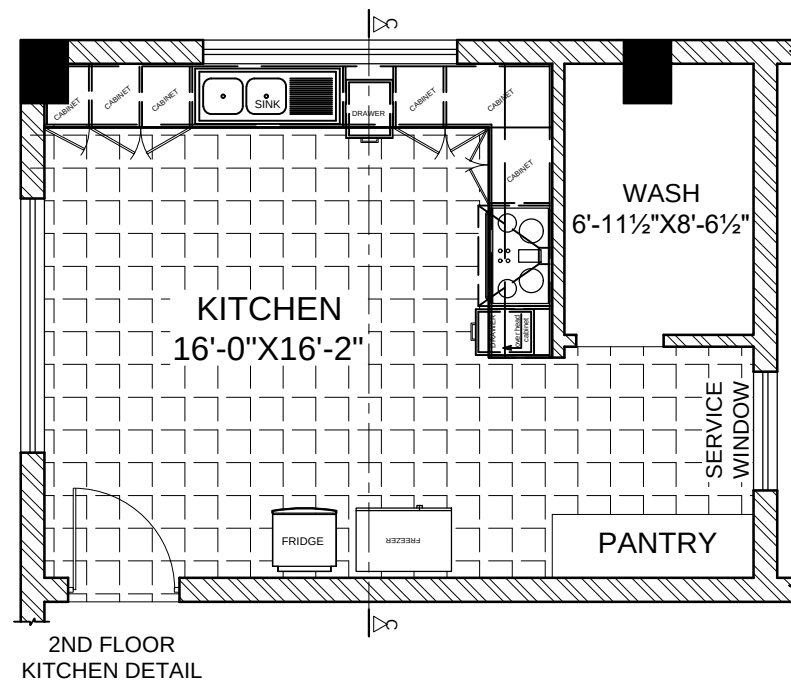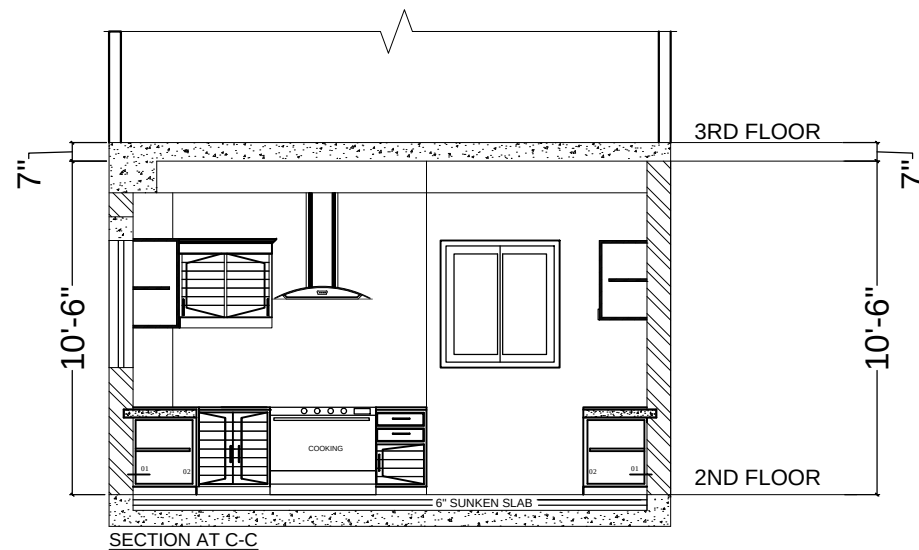

Project

ANTI-NARCOTIC FORCE ACADEMY
EXTENSION AND WOMEN'S HOSTEL

Client

UNITED NATIONS DEVELOPMENT PROGRAMME

Funding Agency

INTERNATIONAL NARCOTICS AND LAW
ENFORCEMENT AFFAIRS (INL)


Consultant

GSK ENGINEERZ

PLANNING - TESTING - DESIGNING & DEVELOPMENT
FLAT NO.205 & 206 2nd Floor, Afzal Tower Phase 3,
Main Intersection, Peshawar
Ph: +92-333-912-6118, +92-334-843-5340
E-mail: gsk.engineerz@gmail.com

SCALE : N.T.S	ARCHITECT : M.IQBAL	
SHEET NO : AR - 16A	PREPARED BY : GHANI REHMAN	
DATE : AUG - 2021	DRAWING TITLE : KITCHEN DETAIL	
ARCHITECTURAL DRAWING		



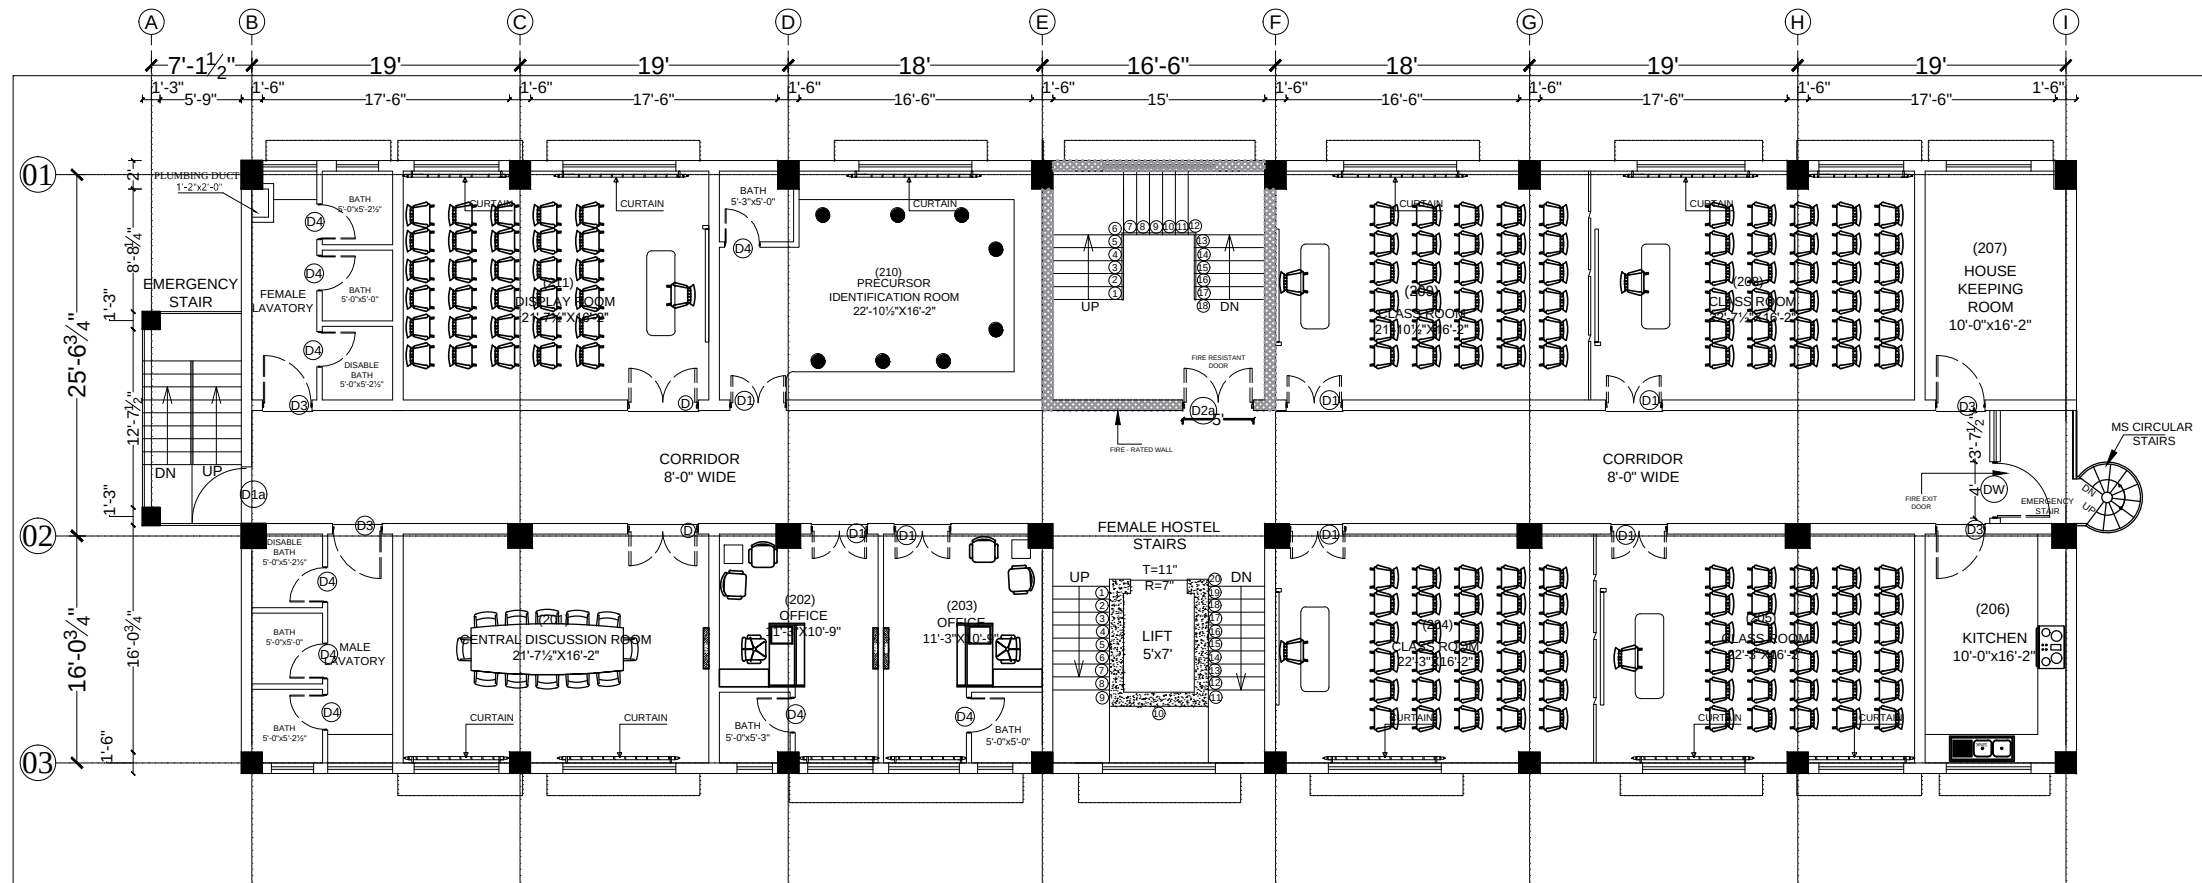

FIRST FLOOR PLAN

Project

ANTI-NARCOTIC FORCE ACADEMY
EXTENSION AND WOMEN'S HOSTEL

Client

UNITED NATIONS DEVELOPMENT PROGRAMME

Funding Agency


INTERNATIONAL NARCOTICS AND LAW
ENFORCEMENT AFFAIRS (INL)


Consultant

GSK
ENGINEERZ

GSK ENGINEERZ
PLANNING - TESTING - DESIGNING & DEVELOPMENT
FLAT NO.205 & 206 2nd Floor, Afzal Tower Phase 3,
Main Intersection, Peshawar
Ph: +92-333-912-6118, +92-334-843-5340
E-mail: gsk-engineerz@gmail.com

SCALE : N.T.S	ARCHITECT : M.IQBAL	
SHEET NO : AR - 17	PREPARED BY : GHANI REHMAN	
DATE : AUG - 2021	DRAWING TITLE : FIRST FLOOR FURNITURE	
ARCHITECTURAL DRAWING		

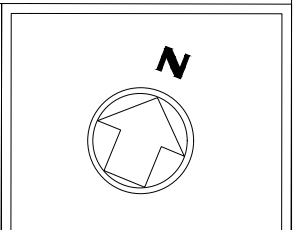

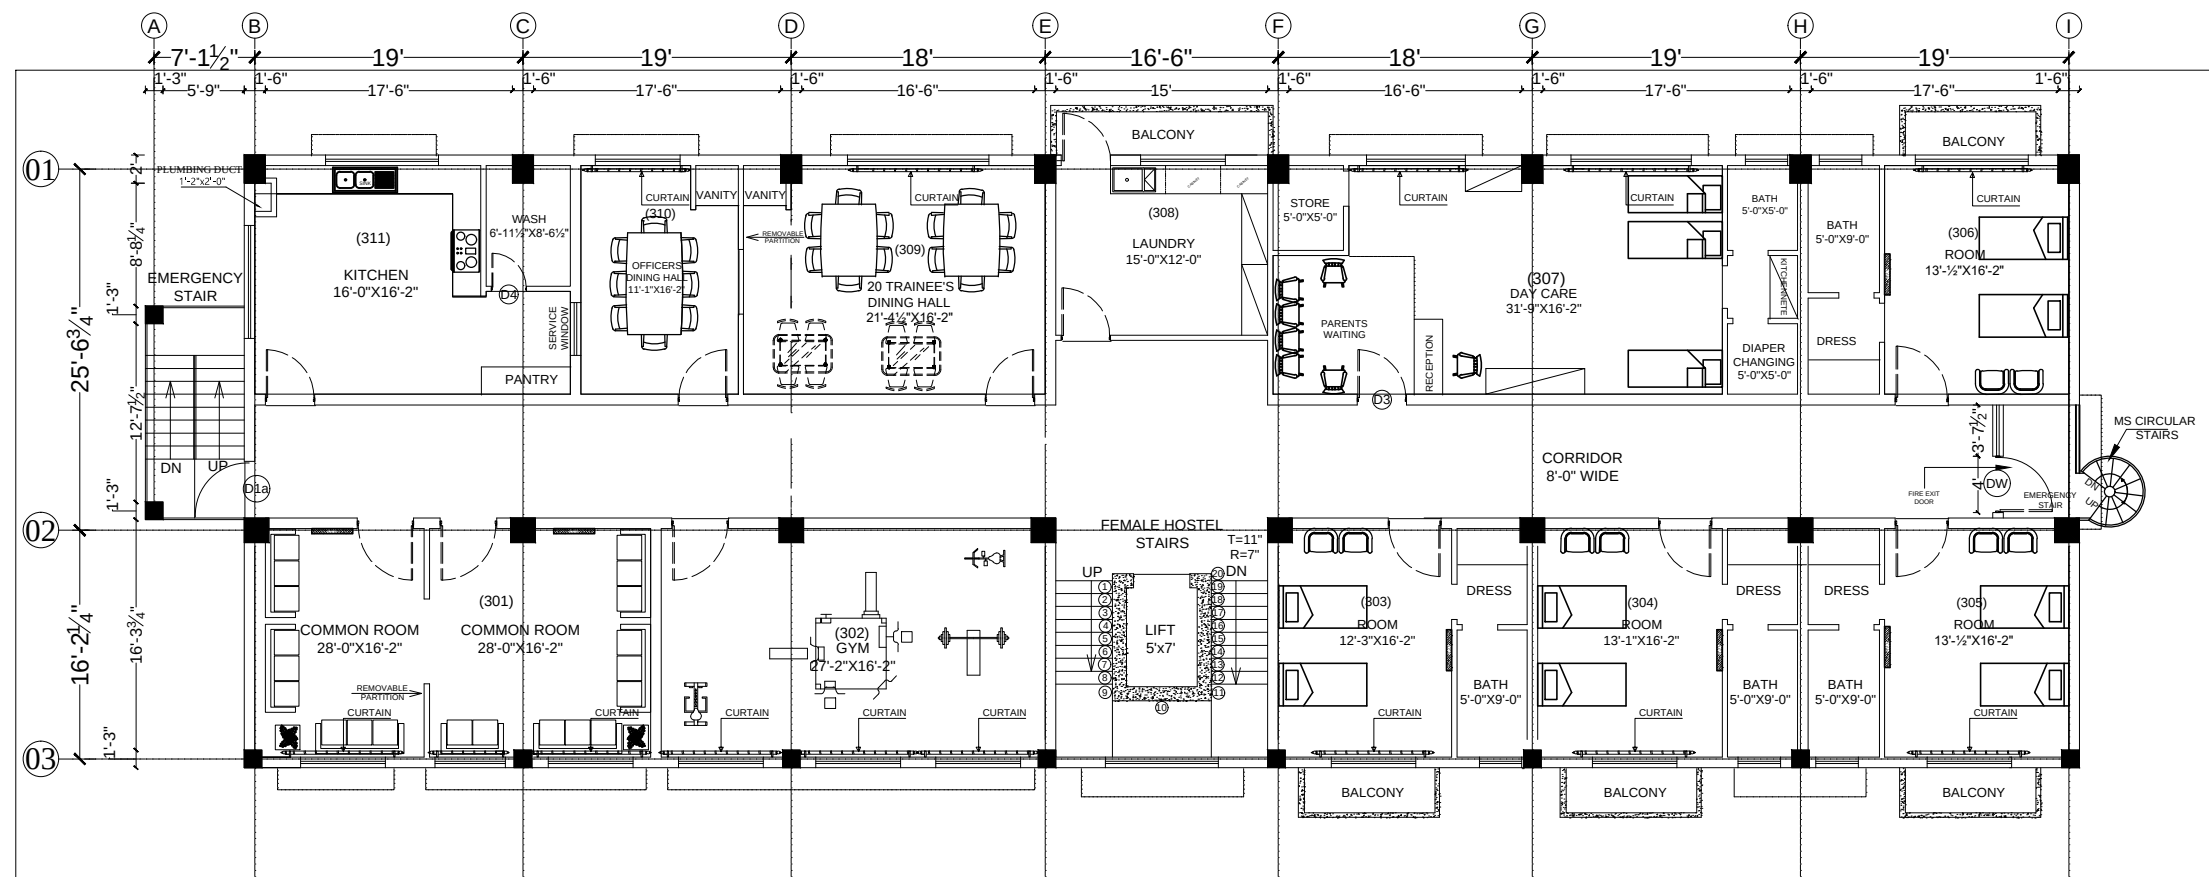

2ND FLOOR PLAN


Project

ANTI-NARCOTIC FORCE ACADEMY
EXTENSION AND WOMEN'S HOSTEL

Client

UNITED NATIONS DEVELOPMENT PROGRAMME
Funding Agency
INTERNATIONAL NARCOTICS AND LAW
ENFORCEMENT AFFAIRS (INL)


Consultant

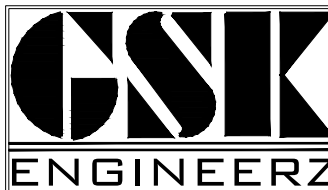

GSK ENGINEERZ
PLANNING - TESTING - DESIGNING & DEVELOPMENT
FLAT NO. 205 & 206 2nd Floor, Afzal Tower Phase 3,
Main Intersection, Peshawar
Ph: +92-333-912-6118, +92-334-843-5340
E-mail: gsk-engineerz@gmail.com

SCALE : N.T.S	ARCHITECT : M.IQBAL	
SHEET NO : AR - 18	PREPARED BY : GHANI REHMAN	
DATE : AUG - 2021	DRAWING TITLE : SECOND FLOOR FURNITURE	
ARCHITECTURAL DRAWING		



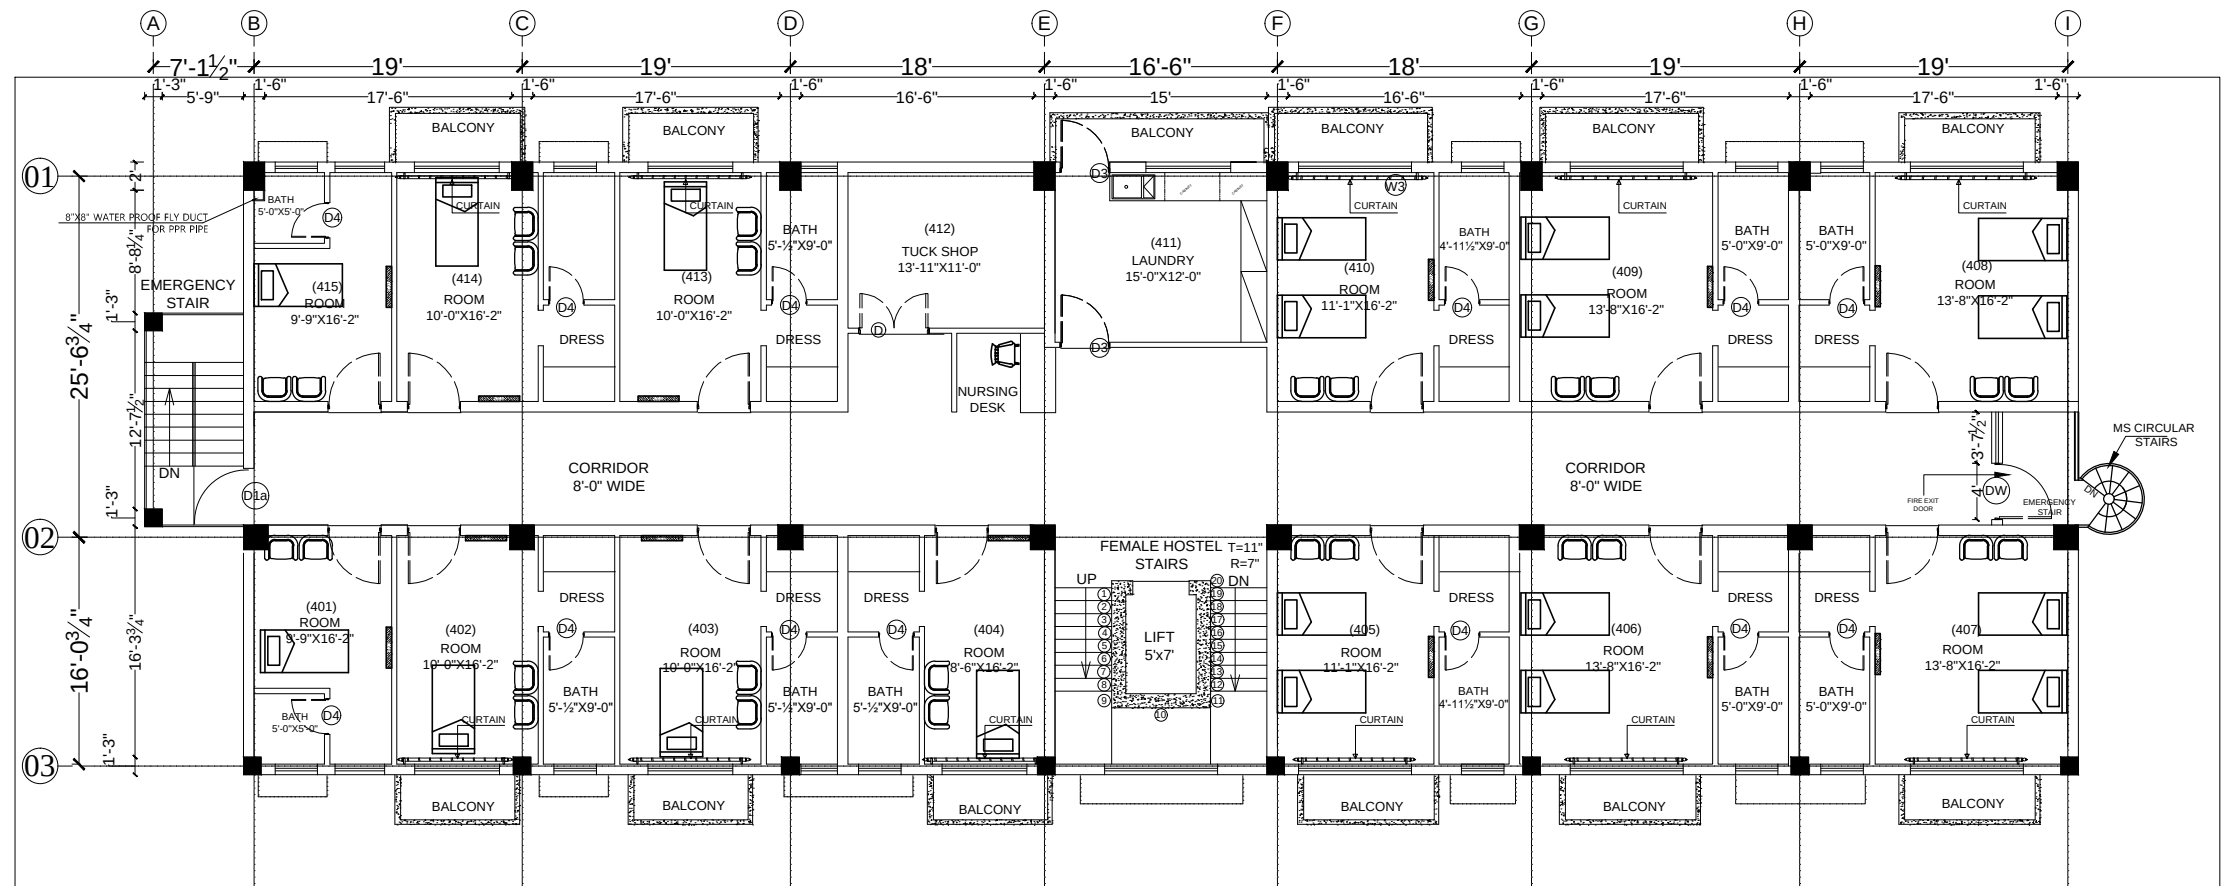

3RD FLOOR PLAN

Project

ANTI-NARCOTIC FORCE ACADEMY
EXTENSION AND WOMEN'S HOSTEL


Client

UNITED NATIONS DEVELOPMENT PROGRAMME

Funding Agency

INTERNATIONAL NARCOTICS AND LAW
ENFORCEMENT AFFAIRS (INL)


Consultant

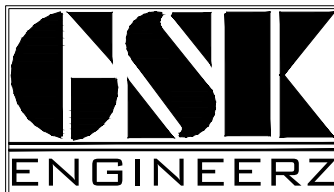

GSK ENGINEERZ
PLANNING - TESTING - DESIGNING & DEVELOPMENT
FLAT NO.205 & 206 2nd Floor, Afzal Tower Phase 3,
Main Intersection, Peshawar
Ph: +92-333-912-6118, +92-334-843-5340
E-mail: gsk-engineerz@gmail.com

SCALE: N.T.S	ARCHITECT: M.IQBAL	
SHEET NO: AR - 19	PREPARED BY: GHANI REHMAN	
DATE: AUG - 2021	DRAWING TITLE: 3RD FLOOR FURNITURE	
ARCHITECTURAL DRAWING		



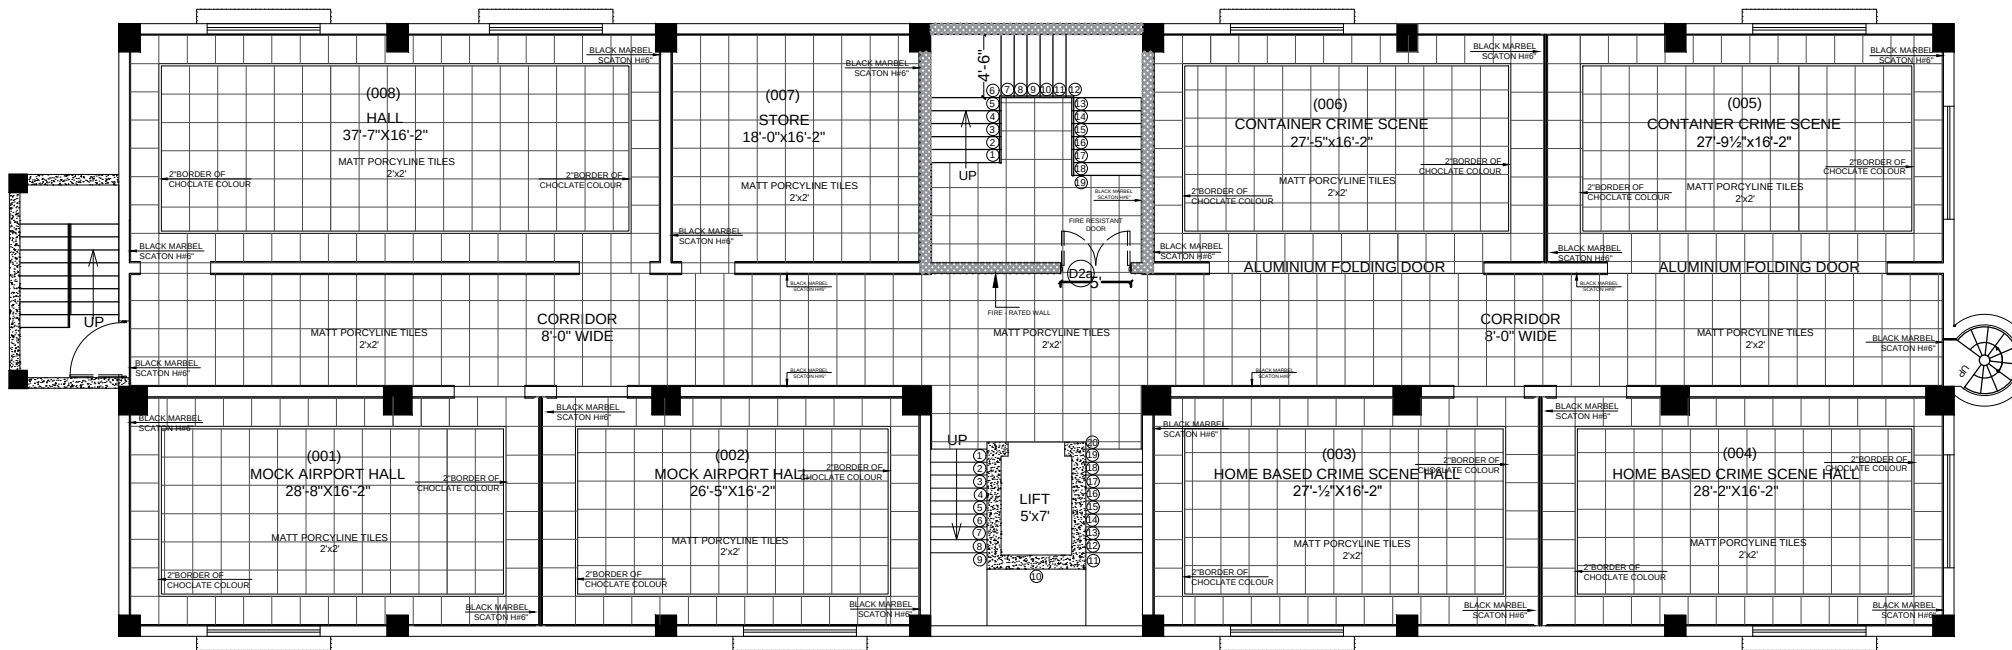

BASEMENT PLAN

Project

ANTI-NARCOTIC FORCE ACADEMY
EXTENSION AND WOMEN'S HOSTEL


Client

UNITED NATIONS DEVELOPMENT PROGRAMME

Funding Agency

INTERNATIONAL NARCOTICS AND LAW
ENFORCEMENT AFFAIRS (INL)

Consultant

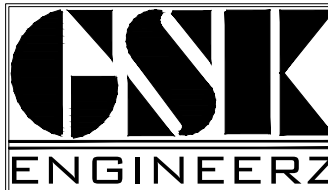


GSK ENGINEERZ

PLANNING - TESTING - DESIGNING & DEVELOPMENT
FLAT NO.205 & 206 2nd Floor, Afzal Tower Phase 3,
Main Intersection, Peshawar
Ph: +92-333-912-6118, +92-334-843-5340
E-mail: gsk-engineerz@gmail.com

SCALE : N.T.S	ARCHITECT : M.IQBAL	
SHEET NO : AR - 20	PREPARED BY : GHANI REHMAN	
DATE : AUG - 2021	DRAWING TITLE : BASEMENT FLOORING	
ARCHITECTURAL DRAWING		



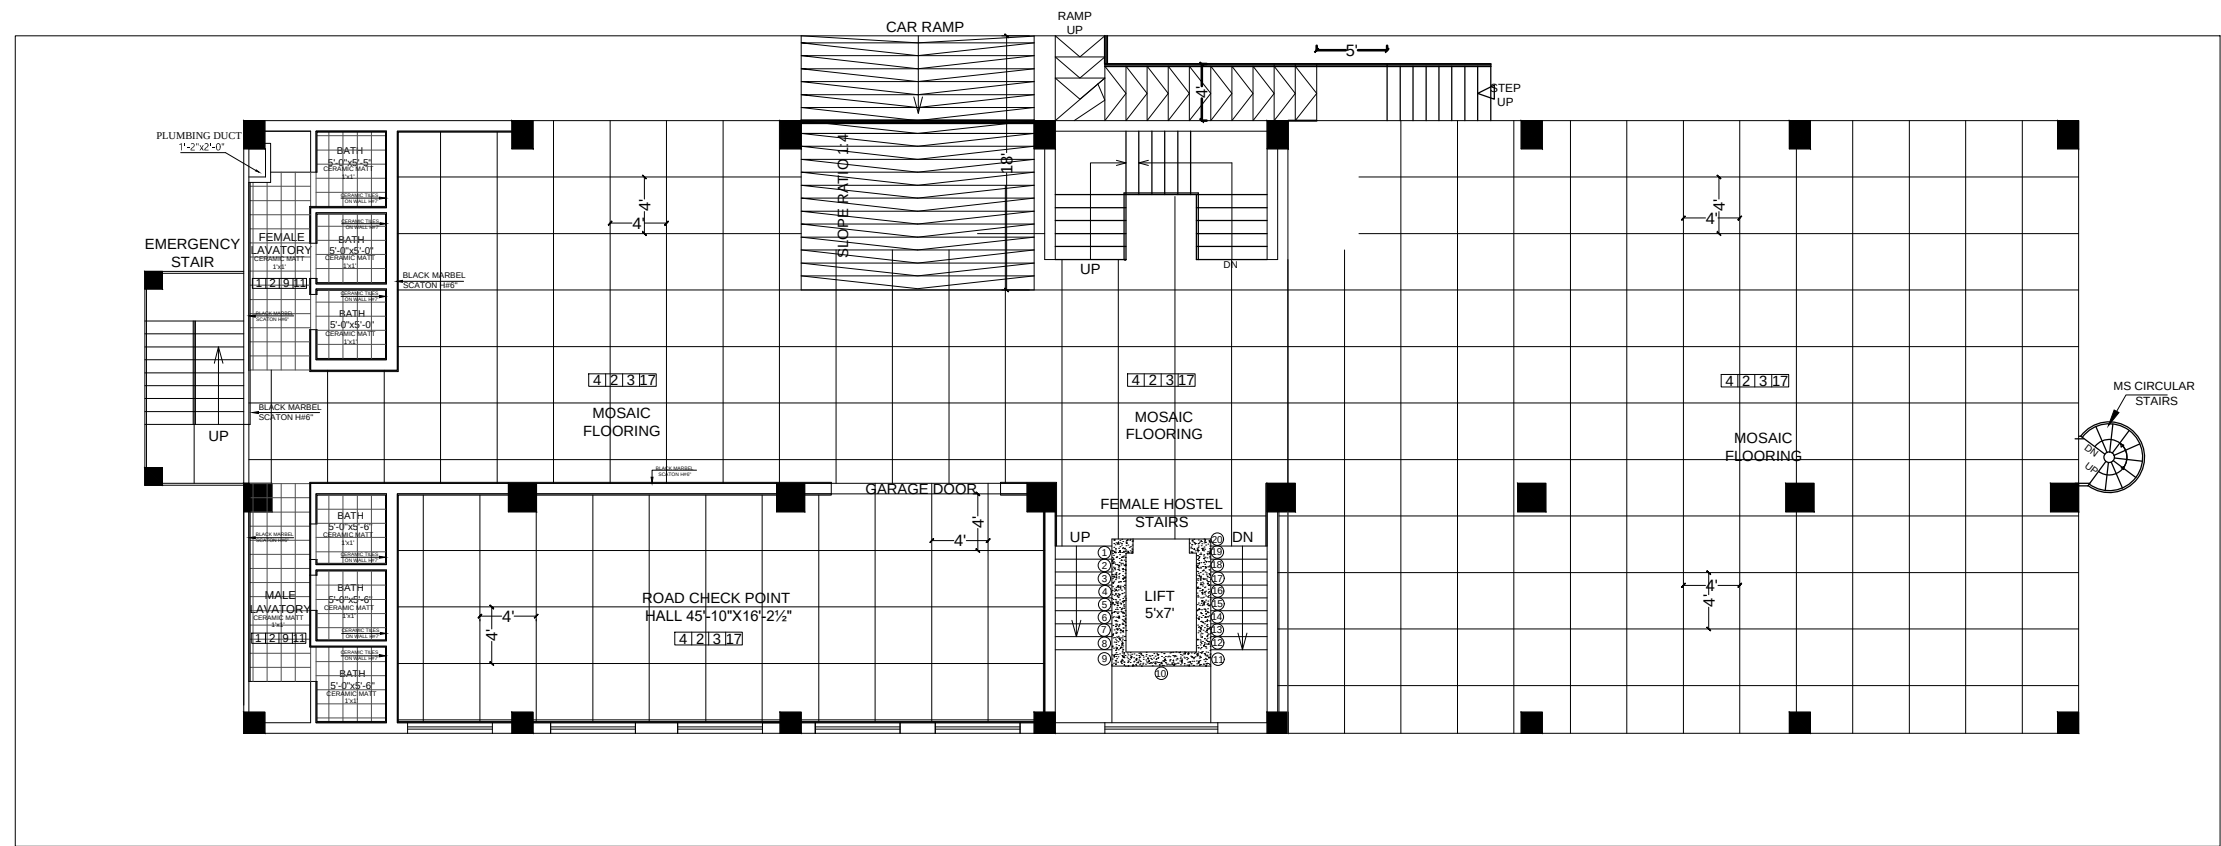

GROUND FLOOR PLAN

Project

ANTI-NARCOTIC FORCE ACADEMY
EXTENSION AND WOMEN'S HOSTEL


Client

UNITED NATIONS DEVELOPMENT PROGRAMME

Funding Agency

INTERNATIONAL NARCOTICS AND LAW
ENFORCEMENT AFFAIRS (INL)


Consultant

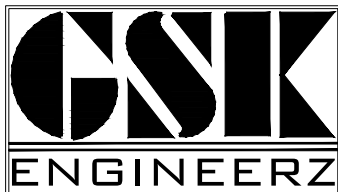

GSK ENGINEERZ
PLANNING - TESTING - DESIGNING & DEVELOPMENT
FLAT NO.205 & 206 2nd Floor, Afzal Tower Phase 3,
Main Intersection, Peshawar
Ph: +92-333-912-6118, +92-334-843-5340
E-mail: gsk-engineerz@gmail.com

SCALE : N.T.S	ARCHITECT : M.IQBAL	
SHEET NO: AR -21	PREPARED BY : GHANI REHMAN	
DATE : AUG - 2021	DRAWING TITLE:	GROUND FLOOR FLORING
ARCHITECTURAL DRAWING		



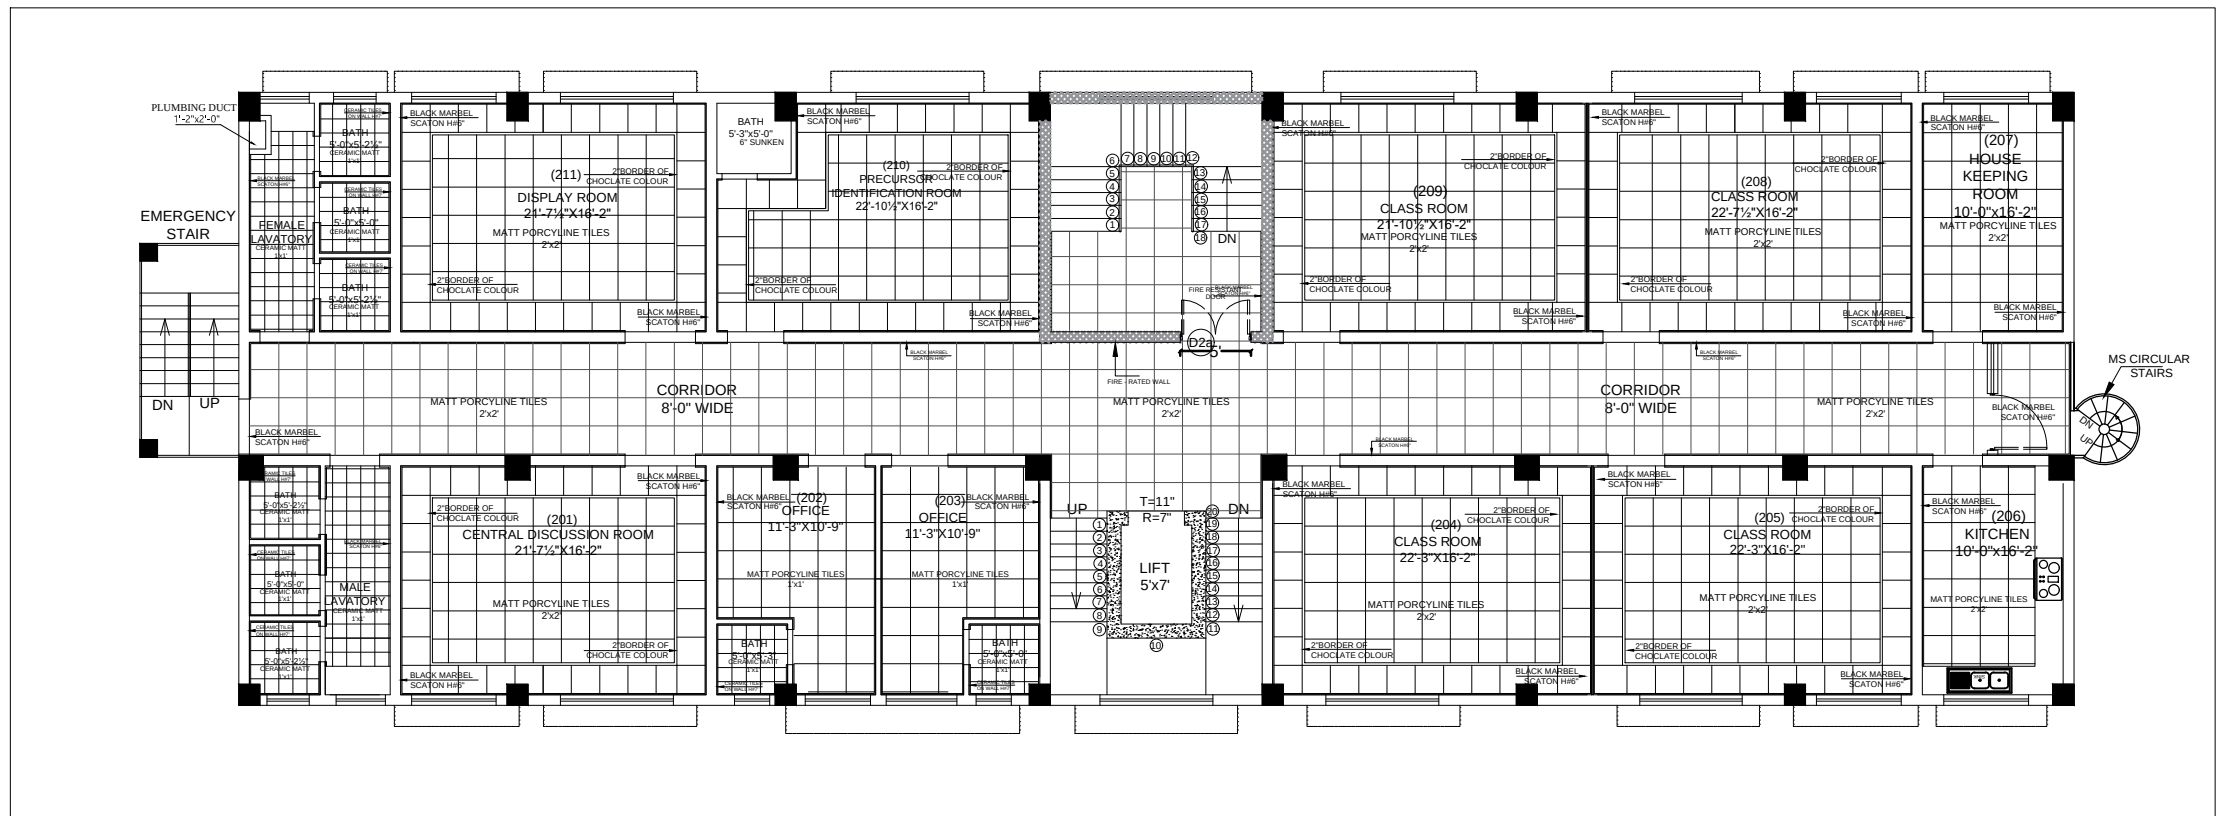

FIRST FLOOR PLAN

Project

ANTI-NARCOTIC FORCE ACADEMY
EXTENSION AND WOMEN'S HOSTEL


Client

UNITED NATIONS DEVELOPMENT PROGRAMME

Funding Agency

INTERNATIONAL NARCOTICS AND LAW
ENFORCEMENT AFFAIRS (INL)


Consultant

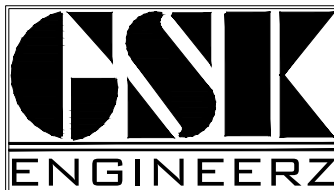

GSK ENGINEERZ
PLANNING - TESTING - DESIGNING & DEVELOPMENT
FLAT NO.205 & 206 2nd Floor, Afzal Tower Phase 3,
Main Intersection, Peshawar
Ph: +92-333-912-6118, +92-334-843-5340
E-mail: gsk-engineerz@gmail.com

SCALE : N.T.S	ARCHITECT : M.IQBAL	
SHEET NO : AR - 22	PREPARED BY : GHANI REHMAN	
DATE : AUG - 2021	DRAWING TITLE : FIRST FLOOR FLOORING	
ARCHITECTURAL DRAWING		



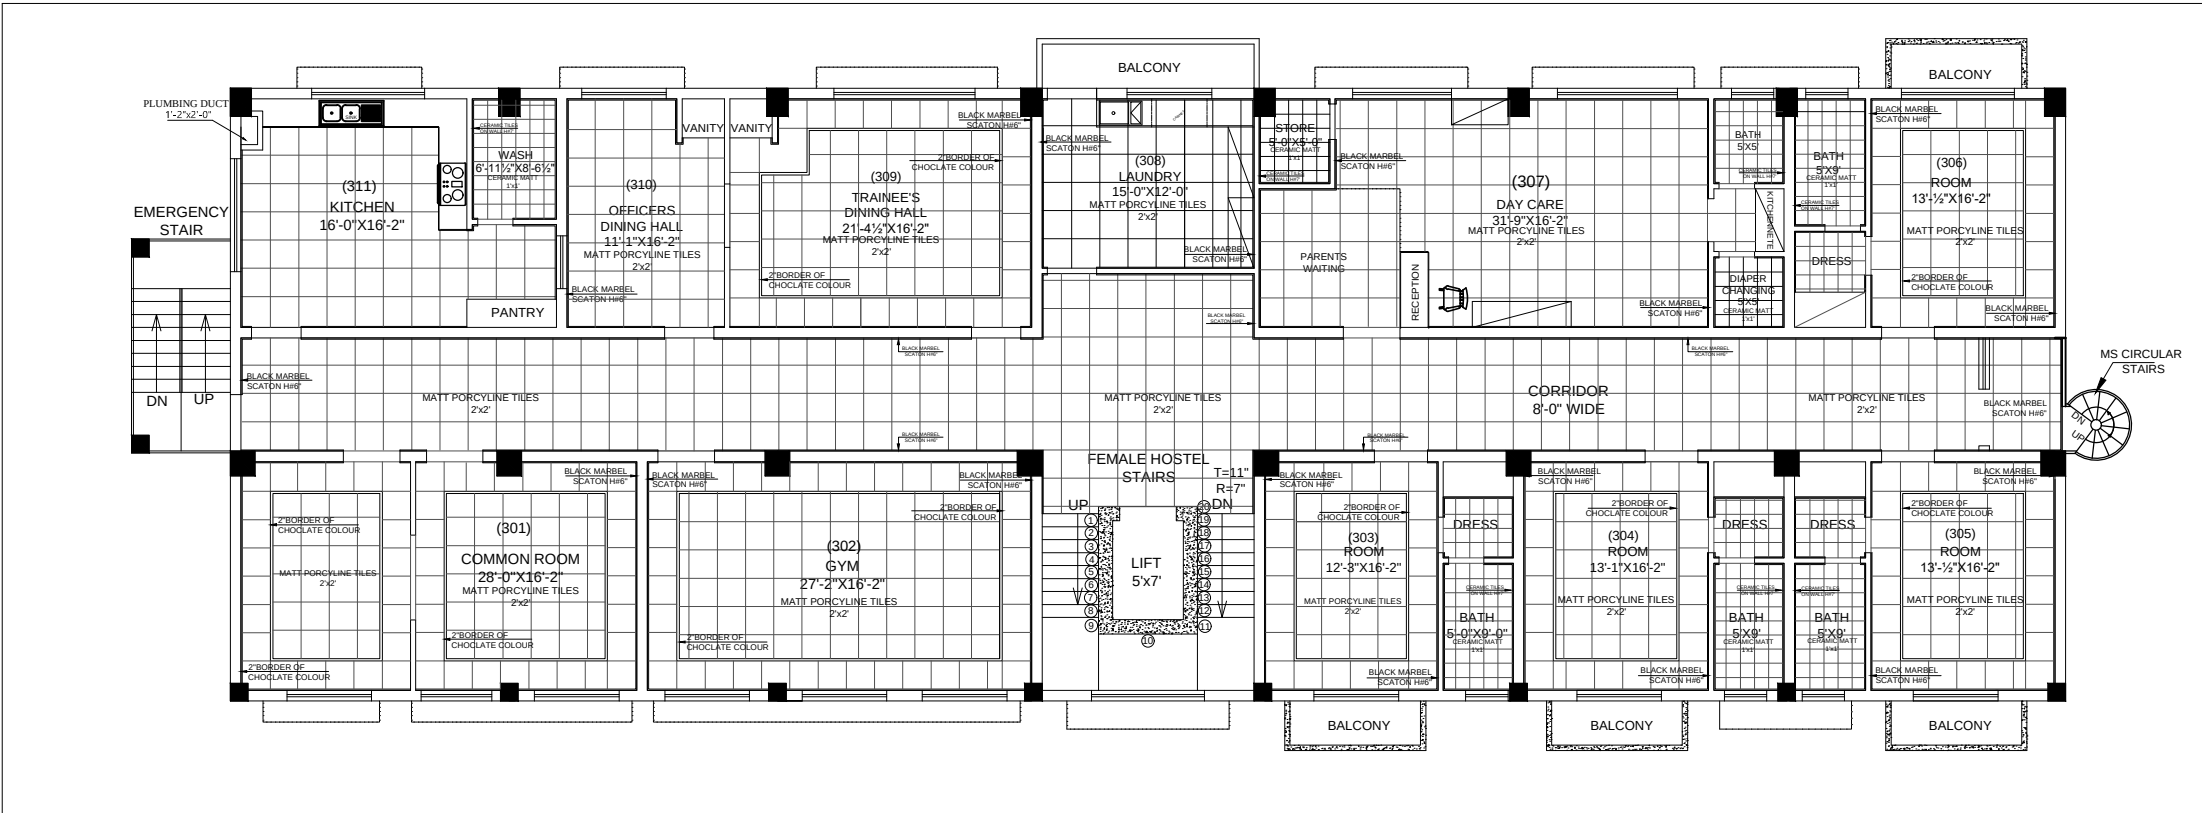

2ND FLOOR PLAN

Project

ANTI-NARCOTIC FORCE ACADEMY
EXTENSION AND WOMEN'S HOSTEL


Client

UNITED NATIONS DEVELOPMENT PROGRAMME

Funding Agency

INTERNATIONAL NARCOTICS AND LAW
ENFORCEMENT AFFAIRS (INL)

Consultant

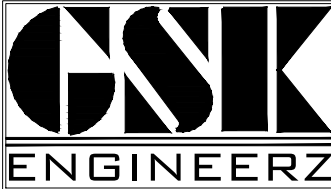


GSK ENGINEERZ

PLANNING - TESTING - DESIGNING & DEVELOPMENT
FLAT NO.205 & 206 2nd Floor, Afzal Tower Phase 3,
Main Intersection, Peshawar
Ph: +92-333-912-6118, +92-334-843-5340
E-mail: gsk-engineerz@gmail.com

SCALE : N.T.S	ARCHITECT : M.IQBAL	
SHEET NO : AR -23	PREPARED BY : GHANI REHMAN	
DATE : AUG -2021	DRAWING TITLE : SECOND FLOOR FLOORING	
ARCHITECTURAL DRAWING		



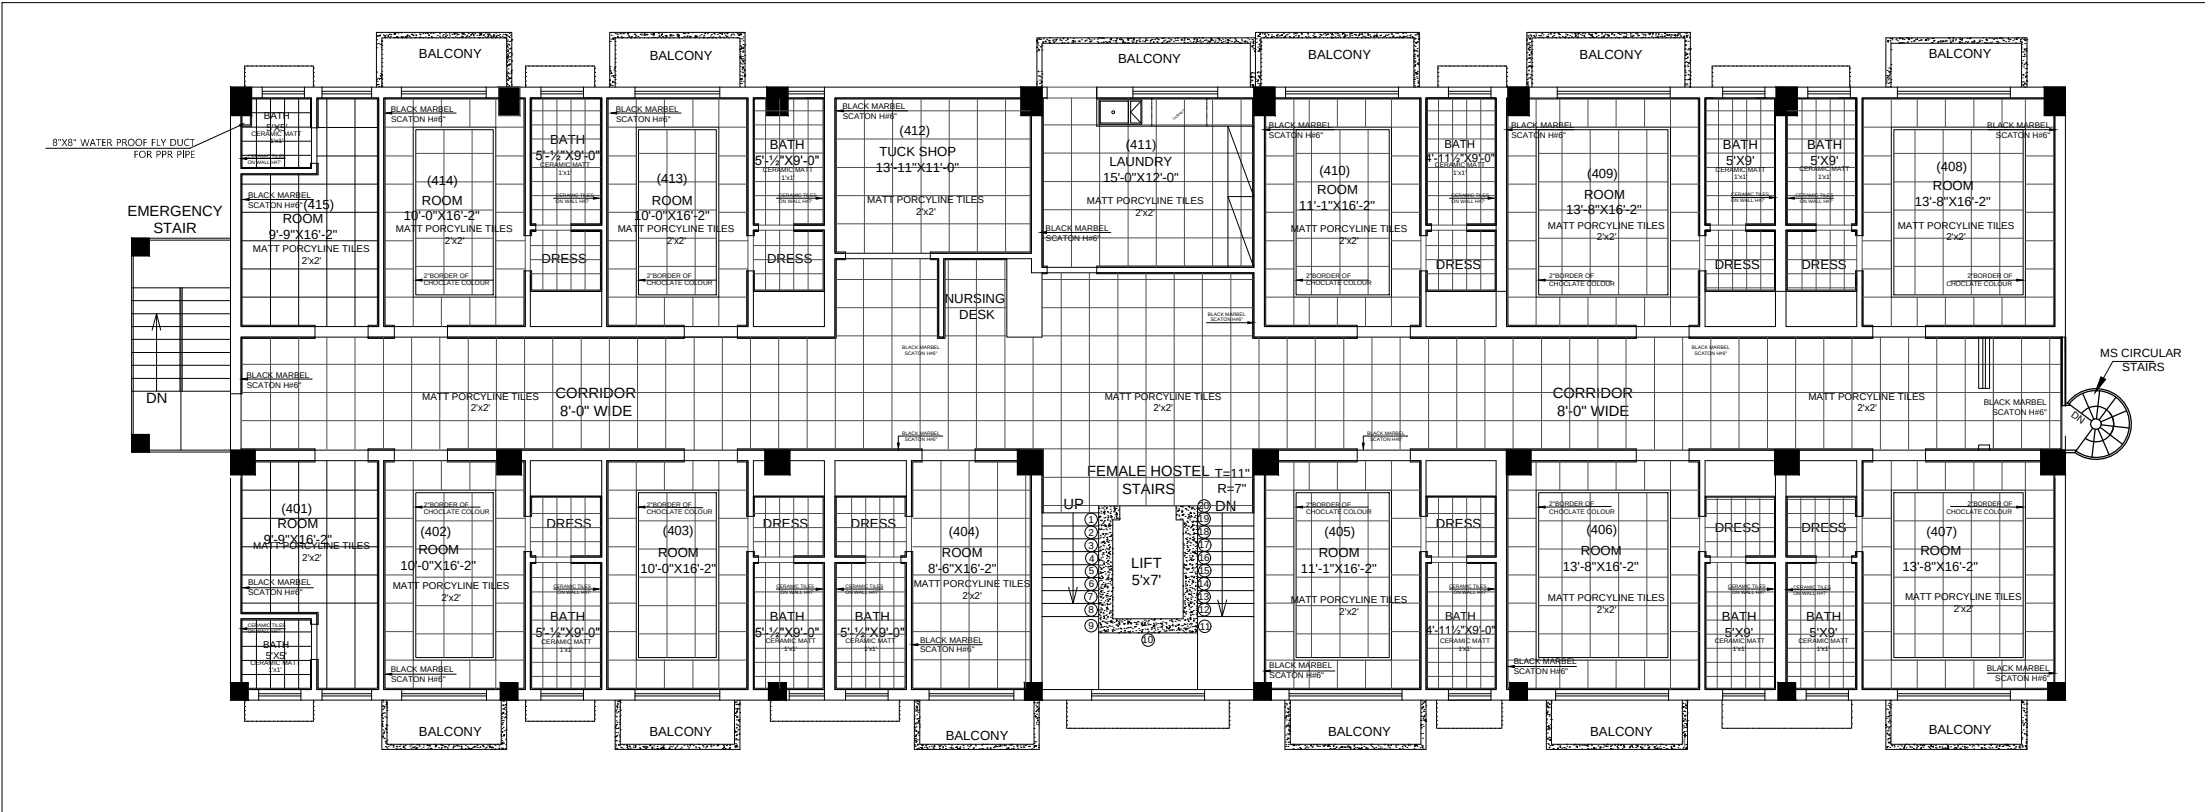

3RD FLOOR PLAN

Project

ANTI-NARCOTIC FORCE ACADEMY
EXTENSION AND WOMEN'S HOSTEL


Client

UNITED NATIONS DEVELOPMENT PROGRAMME

Funding Agency

INTERNATIONAL NARCOTICS AND LAW
ENFORCEMENT AFFAIRS (INL)

Consultant

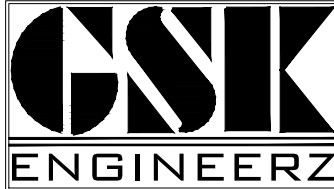


GSK ENGINEERZ

PLANNING - TESTING - DESIGNING & DEVELOPMENT
FLAT NO.205 & 206 2nd Floor, Afzal Tower Phase 3,
Main Intersection, Peshawar
Ph: +92-333-912-6118, +92-334-843-5340
E-mail: gsk-engineerz@gmail.com


SCALE :	N.T.S	ARCHITECT :	M.IQBAL
SHEET NO:	AR -24	PREPARED BY :	GHANI REHMAN
DATE :	AUG -2021	DRAWING TITLE:	3RD FLOOR FLOORING
ARCHITECTURAL DRAWING			



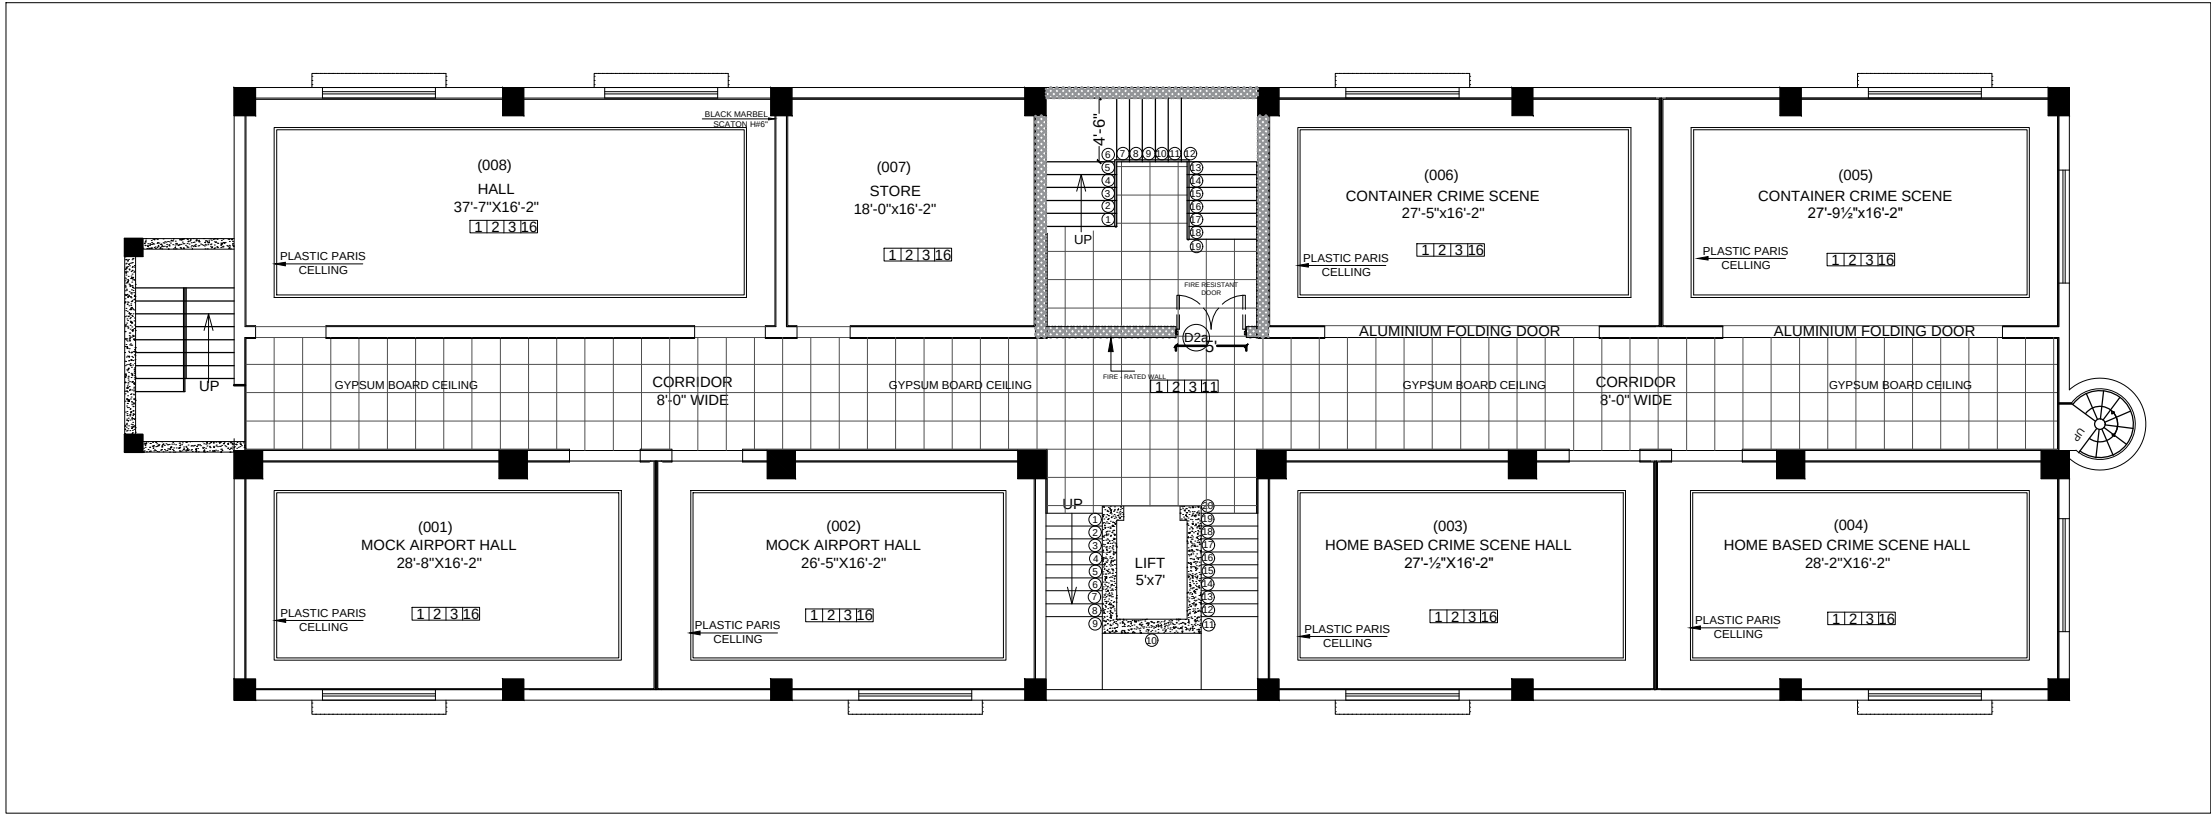

BASEMENT PLAN

Project ANTI-NARCOTIC FORCE ACADEMY EXTENSION AND WOMEN'S HOSTEL	Client UNITED NATIONS DEVELOPMENT PROGRAMME Funding Agency INTERNATIONAL NARCOTICS AND LAW ENFORCEMENT AFFAIRS (INL)	Consultant GSK ENGINEERZ PLANNING - TESTING - DESIGNING & DEVELOPMENT FLAT NO.205 & 206 2nd Floor, Afzal Tower Phase 3, Main Intersection, Peshawar Ph: +92-333-912-6118, +92-334-843-5340 E-mail: gsk-engineerz@gmail.com	<table border="1"><tr><td>SCALE : N.T.S</td><td>ARCHITECT : M.IQBAL</td></tr><tr><td>SHEET NO : AR - 25</td><td>PREPARED BY : GHANI REHMAN</td></tr><tr><td>DATE : AUG - 2021</td><td>DRAWING TITLE : CEILING LAYOUT FOR BASEMENT</td></tr></table> ARCHITECTURAL DRAWING	SCALE : N.T.S	ARCHITECT : M.IQBAL	SHEET NO : AR - 25	PREPARED BY : GHANI REHMAN	DATE : AUG - 2021	DRAWING TITLE : CEILING LAYOUT FOR BASEMENT	
SCALE : N.T.S	ARCHITECT : M.IQBAL									
SHEET NO : AR - 25	PREPARED BY : GHANI REHMAN									
DATE : AUG - 2021	DRAWING TITLE : CEILING LAYOUT FOR BASEMENT									

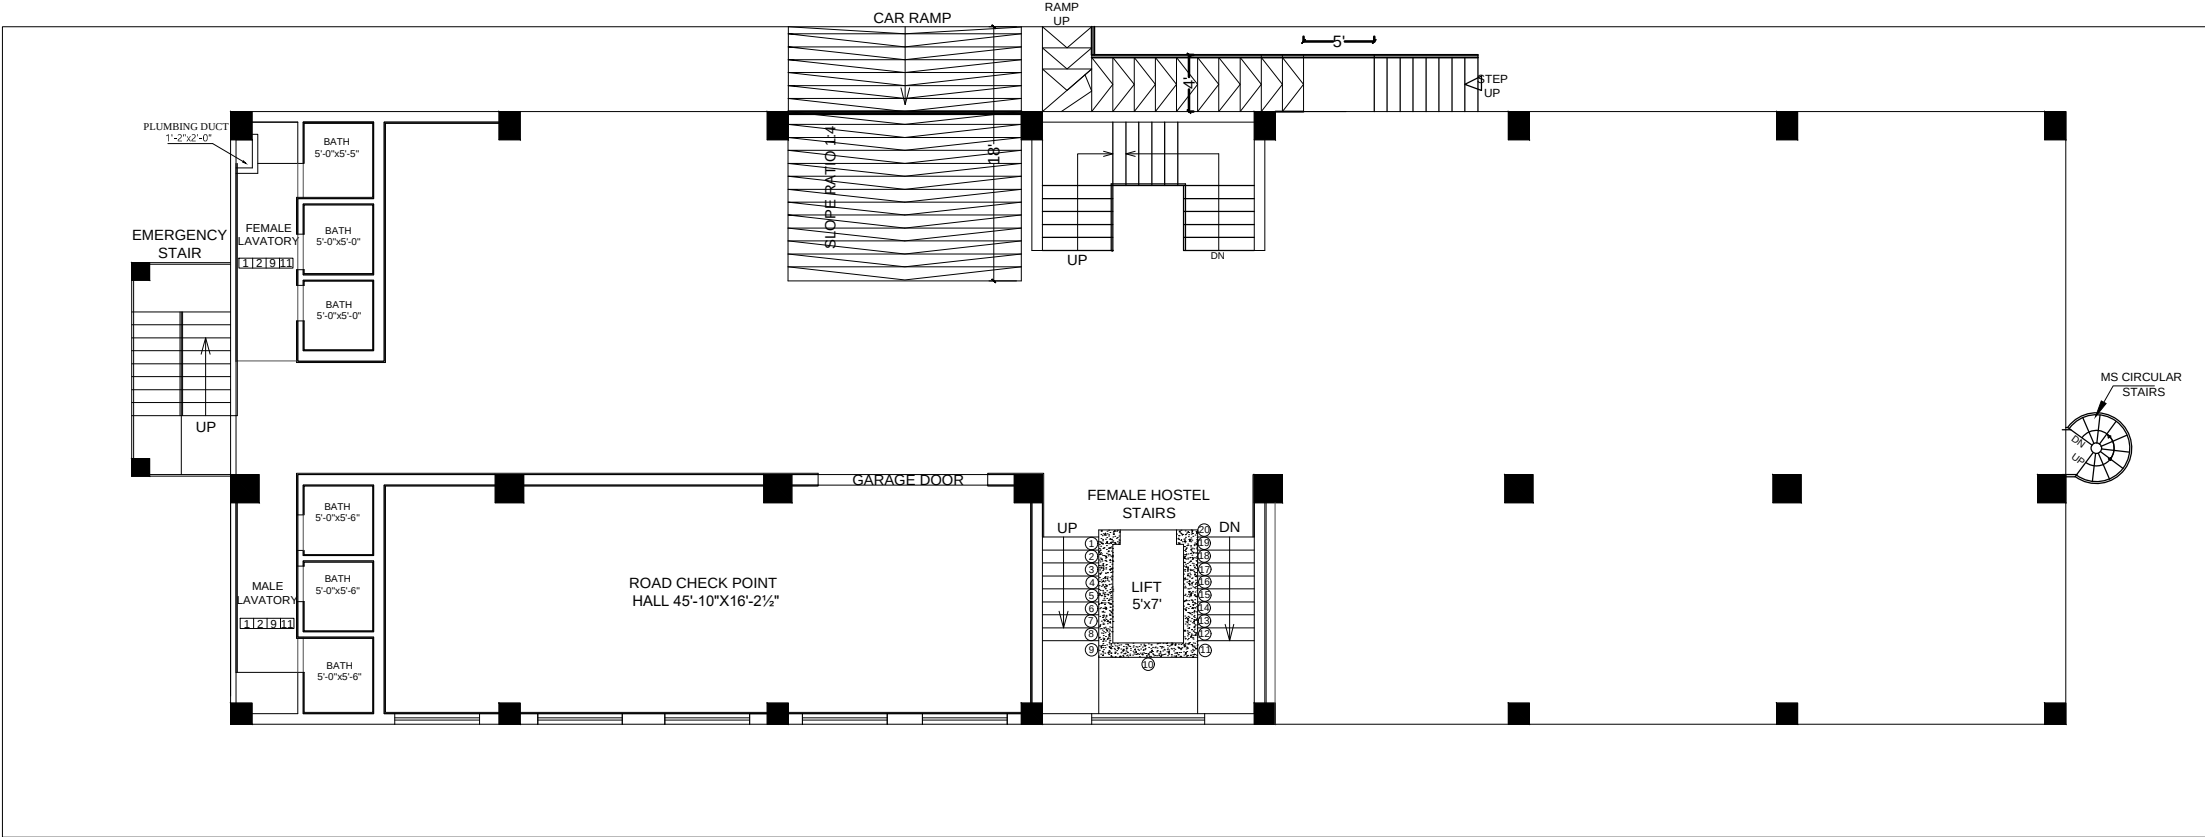

GROUND FLOOR PLAN

Project

ANTI-NARCOTIC FORCE ACADEMY
EXTENSION AND WOMEN'S HOSTEL


Client

UNITED NATIONS DEVELOPMENT PROGRAMME

Funding Agency

INTERNATIONAL NARCOTICS AND LAW
ENFORCEMENT AFFAIRS (INL)

Consultant

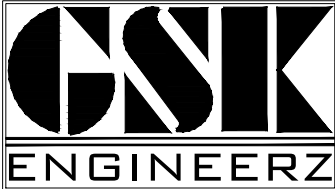


GSK ENGINEERZ

PLANNING - TESTING - DESIGNING & DEVELOPMENT
FLAT NO.205 & 206 2nd Floor, Afzal Tower Phase 3,
Main Intersection, Peshawar
Ph: +92-333-912-6118, +92-334-843-5340
E.mail: gsk.engineerz@gmail.com


SCALE : N.T.S	ARCHITECT : M.IQBAL	
SHEET NO: AR - 26	PREPARED BY : GHANI REHMAN	
DATE : AUG - 2021	DRAWING TITLE:	CEILING LAYOUT FOR GROUND FLOOR
ARCHITECTURAL DRAWING		



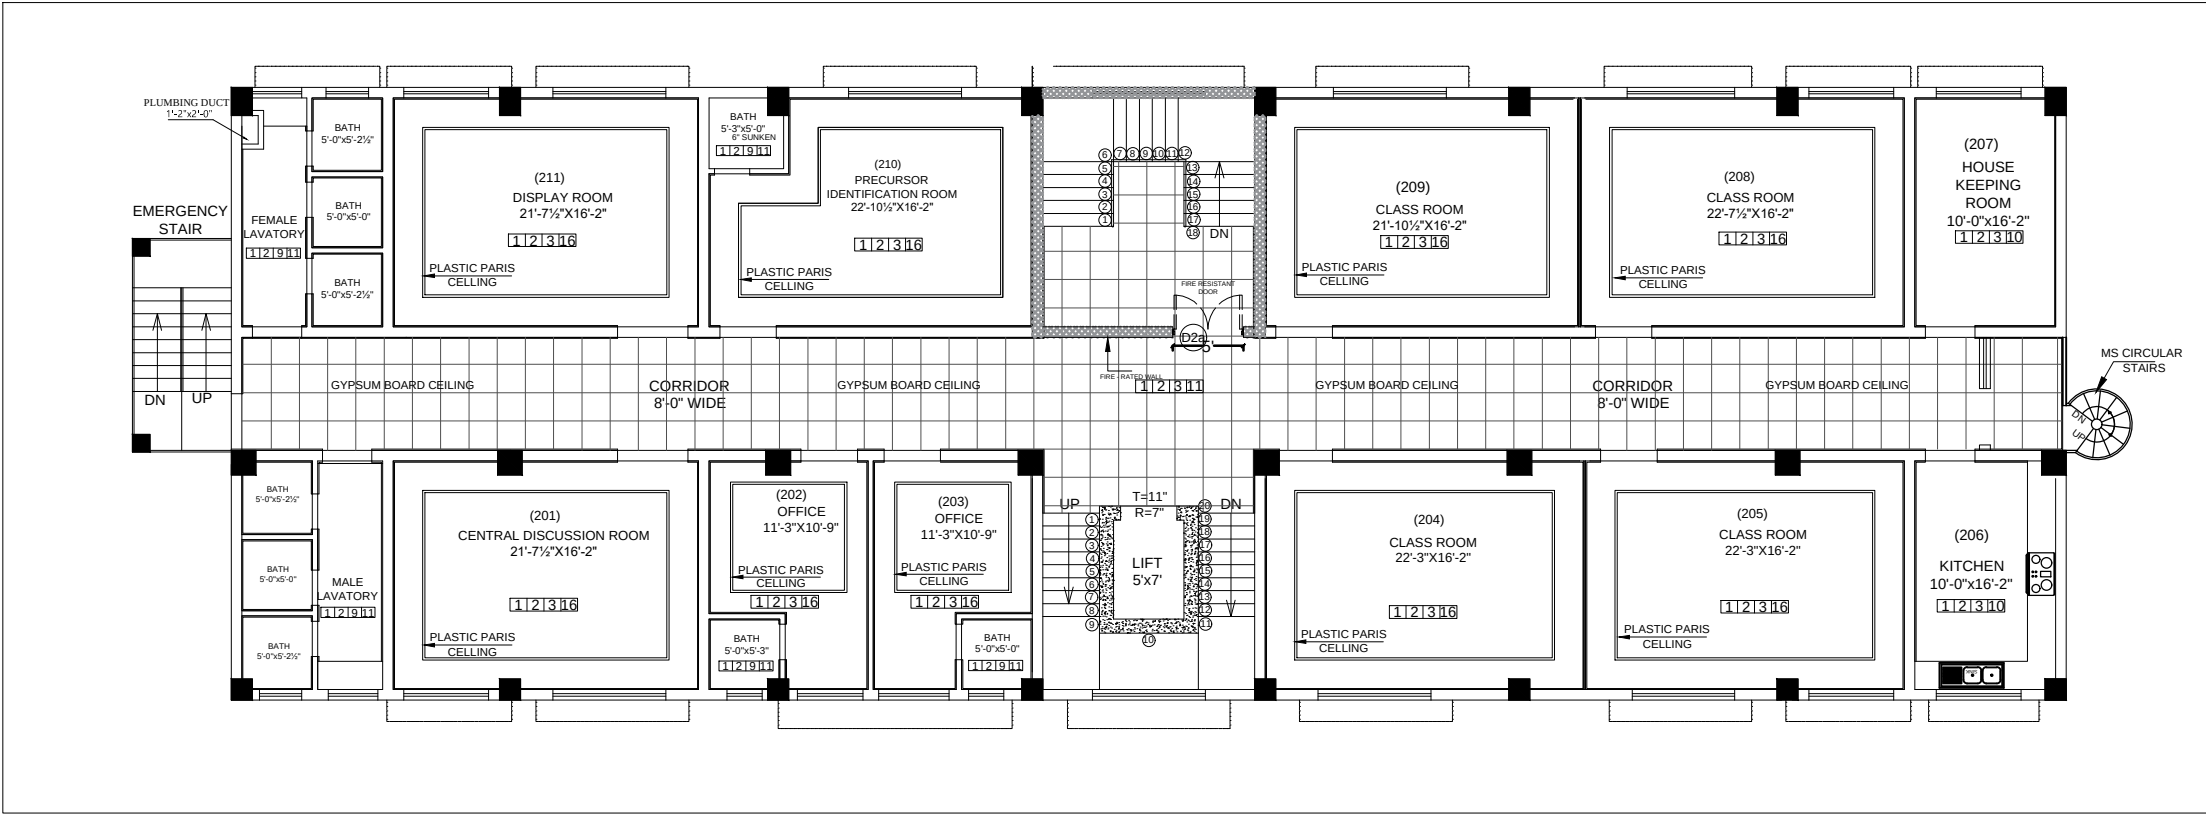

FIRST FLOOR PLAN

Project ANTI-NARCOTIC FORCE ACADEMY EXTENSION AND WOMEN'S HOSTEL	Client UNITED NATIONS DEVELOPMENT PROGRAMME Funding Agency INTERNATIONAL NARCOTICS AND LAW ENFORCEMENT AFFAIRS (INL)	Consultant  GSK ENGINEERZ PLANNING - TESTING - DESIGNING & DEVELOPMENT FLAT NO.205 & 206 2nd Floor, Afzal Tower Phase 3, Main Intersection, Peshawar Ph: +92-333-912-6118, +92-334-843-5340 E.mail: gsk.engineerz@gmail.com	<table><tr><td>SCALE : N.T.S</td><td>ARCHITECT : M.IQBAL</td></tr><tr><td>SHEET NO: AR - 27</td><td>PREPARED BY : GHANI REHMAN</td></tr><tr><td>DATE : AUG - 2021</td><td>DRAWING TITLE: CEILING LAYOUT FOR FIRST FLOOR</td></tr><tr><td colspan="2">ARCHITECTURAL DRAWING</td></tr></table>	SCALE : N.T.S	ARCHITECT : M.IQBAL	SHEET NO: AR - 27	PREPARED BY : GHANI REHMAN	DATE : AUG - 2021	DRAWING TITLE: CEILING LAYOUT FOR FIRST FLOOR	ARCHITECTURAL DRAWING		
SCALE : N.T.S	ARCHITECT : M.IQBAL											
SHEET NO: AR - 27	PREPARED BY : GHANI REHMAN											
DATE : AUG - 2021	DRAWING TITLE: CEILING LAYOUT FOR FIRST FLOOR											
ARCHITECTURAL DRAWING												

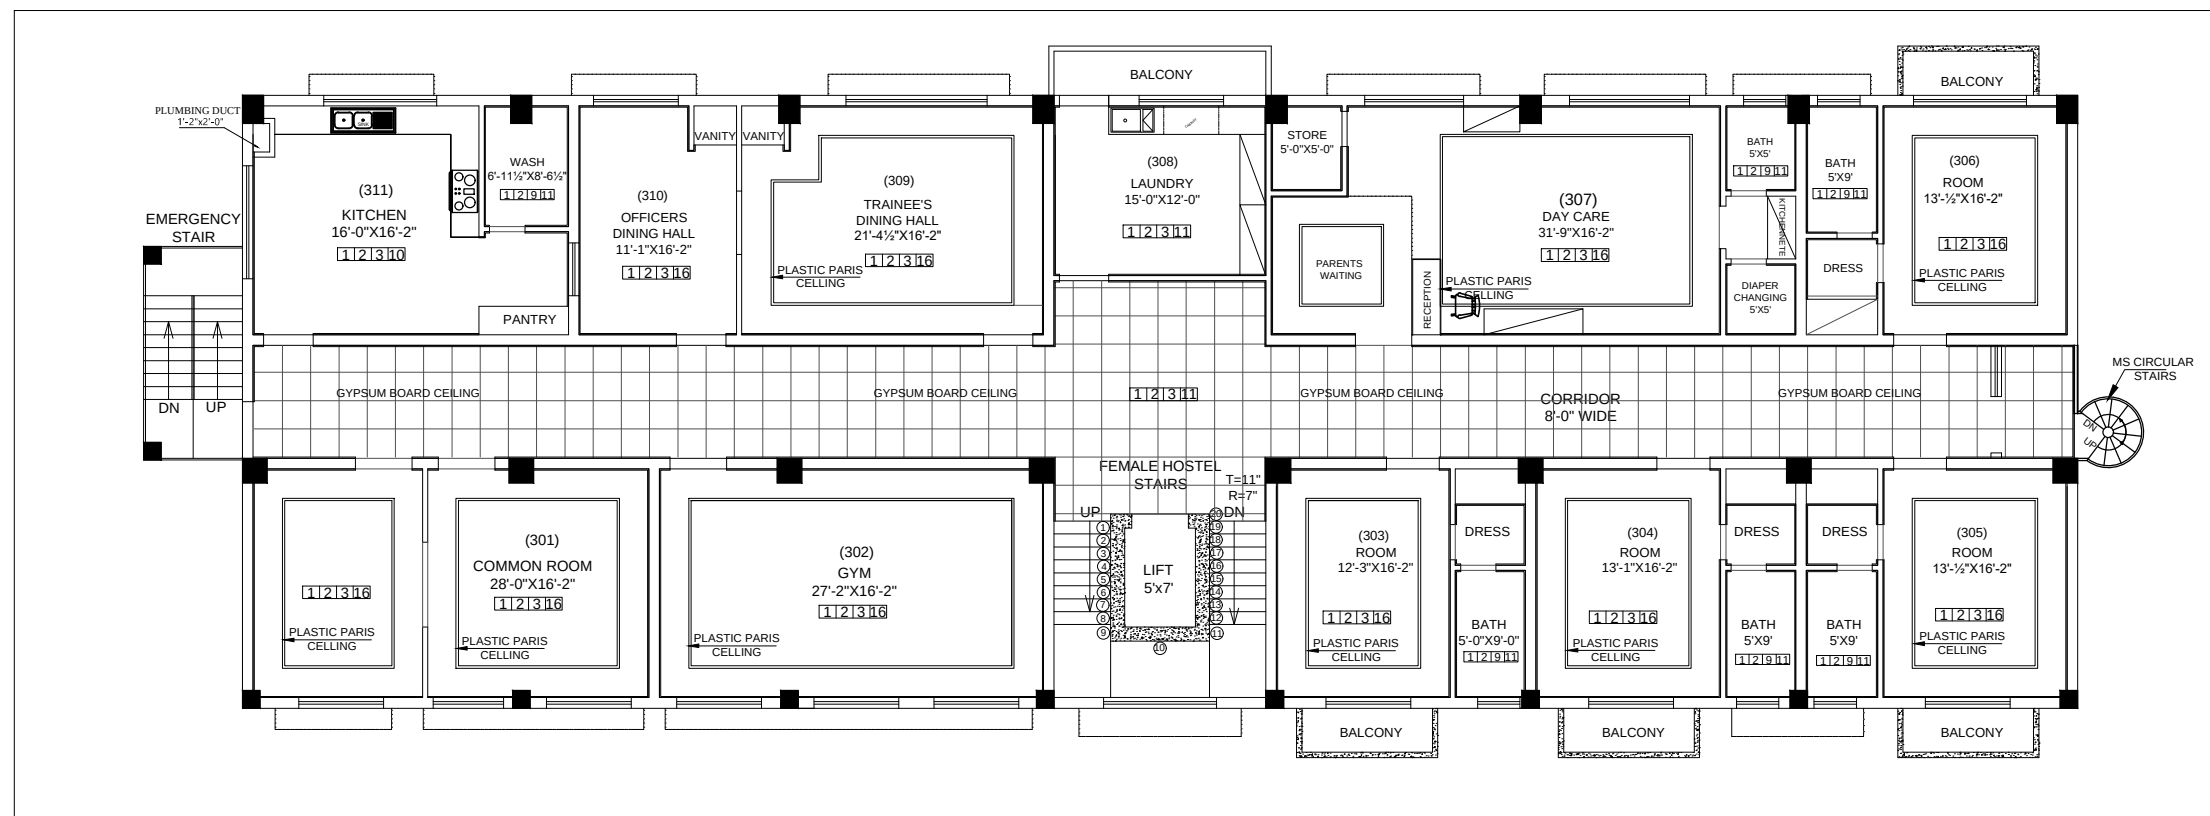

2ND FLOOR PLAN

Project

ANTI-NARCOTIC FORCE ACADEMY
EXTENSION AND WOMEN'S HOSTEL


Client

UNITED NATIONS DEVELOPMENT PROGRAMME

Funding Agency

INTERNATIONAL NARCOTICS AND LAW
ENFORCEMENT AFFAIRS (INL)


Consultant

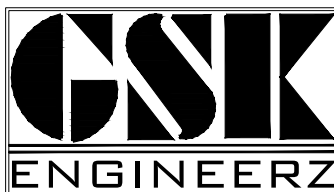

GSK ENGINEERZ
PLANNING - TESTING - DESIGNING & DEVELOPMENT
FLAT NO.205 & 206 2nd Floor, Afzal Tower Phase 3,
Main Intersection, Peshawar
Ph: +92-333-912-6118, +92-334-843-5340
E-mail: gsk-engineerz@gmail.com

SCALE : N.T.S	ARCHITECT : M.IQBAL	
SHEET NO: AR - 28	PREPARED BY : GHANI REHMAN	
DATE : AUG - 2021	DRAWING TITLE: CEILING LAYOUT FOR SECOND FLOOR	
ARCHITECTURAL DRAWING		



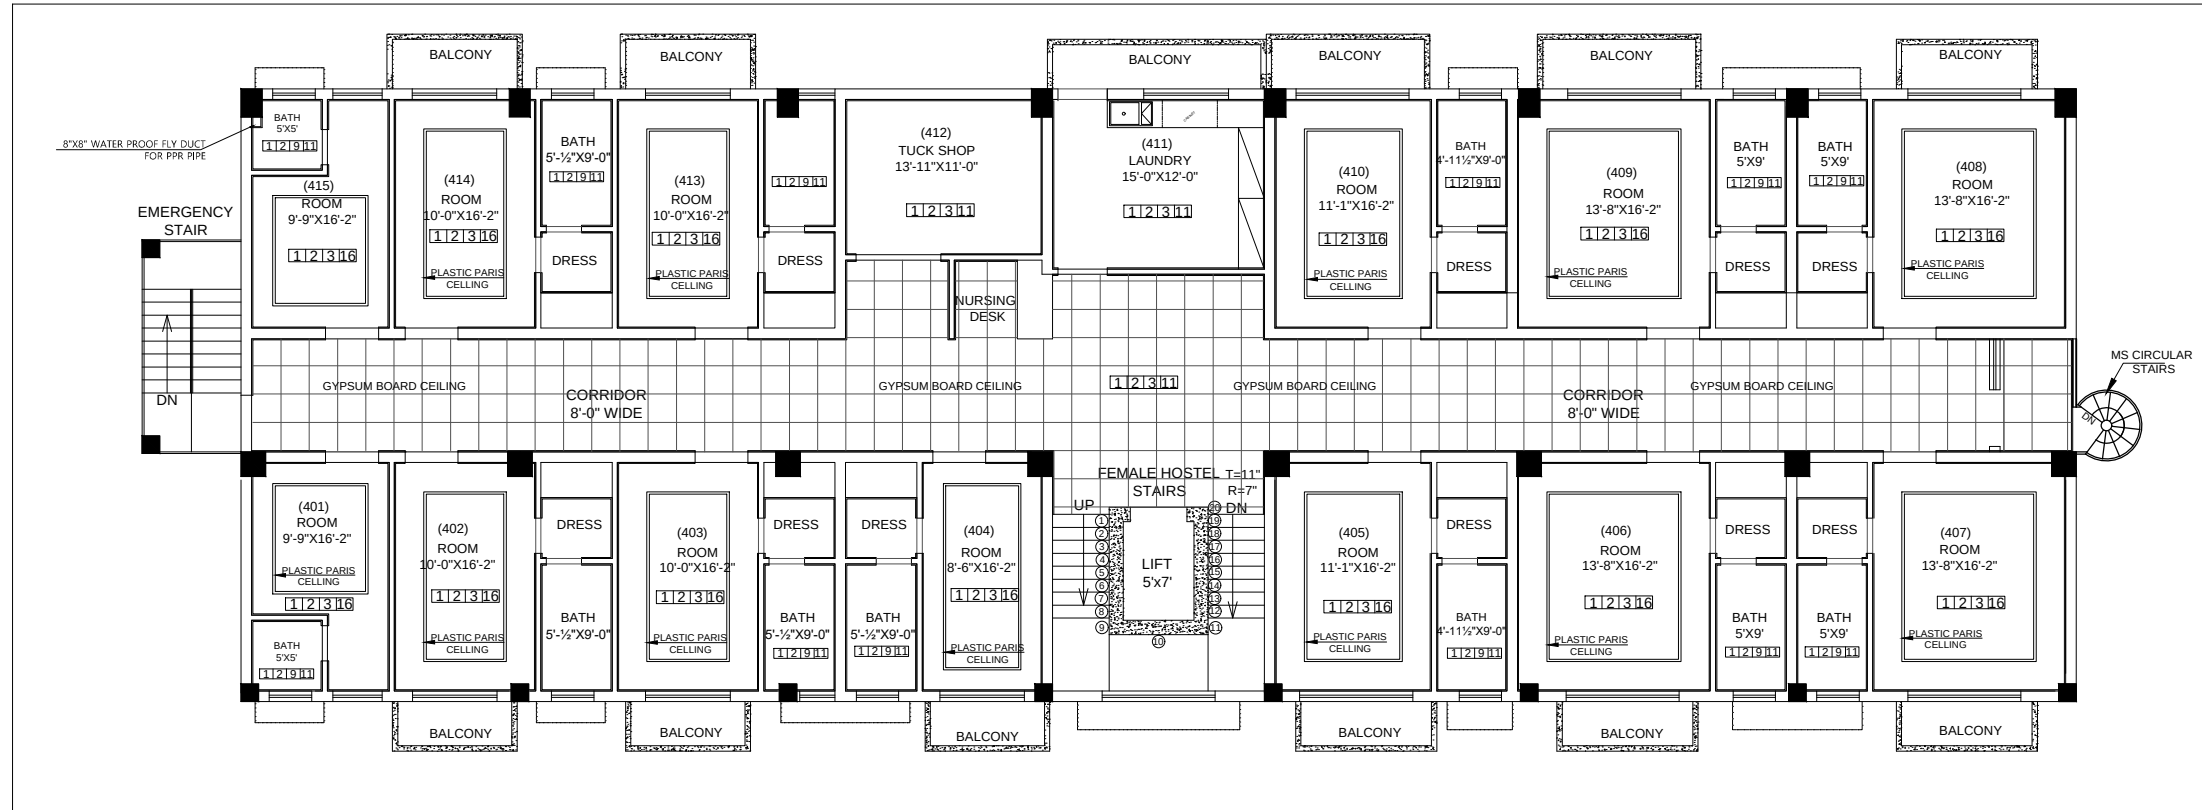

3RD FLOOR PLAN

Project

ANTI-NARCOTIC FORCE ACADEMY
EXTENSION AND WOMEN'S HOSTEL


Client

UNITED NATIONS DEVELOPMENT PROGRAMME

Funding Agency


INTERNATIONAL NARCOTICS AND LAW
ENFORCEMENT AFFAIRS (INL)


Consultant

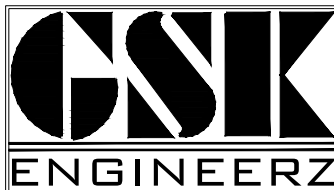

GSK ENGINEERZ
PLANNING - TESTING - DESIGNING & DEVELOPMENT
FLAT NO.205 & 206 2nd Floor, Afzal Tower Phase 3,
Main Intersection, Peshawar
Ph: +92-333-912-6118, +92-334-843-5340
E-mail: gsk-engineerz@gmail.com

SCALE : N.T.S	ARCHITECT : M.IQBAL	
SHEET NO : AR - 29	PREPARED BY : GHANI REHMAN	
DATE : AUG - 2021	DRAWING TITLE : CEILING LAYOUT FOR 3RD FLOOR	
ARCHITECTURAL DRAWING		

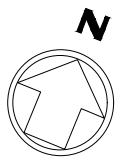

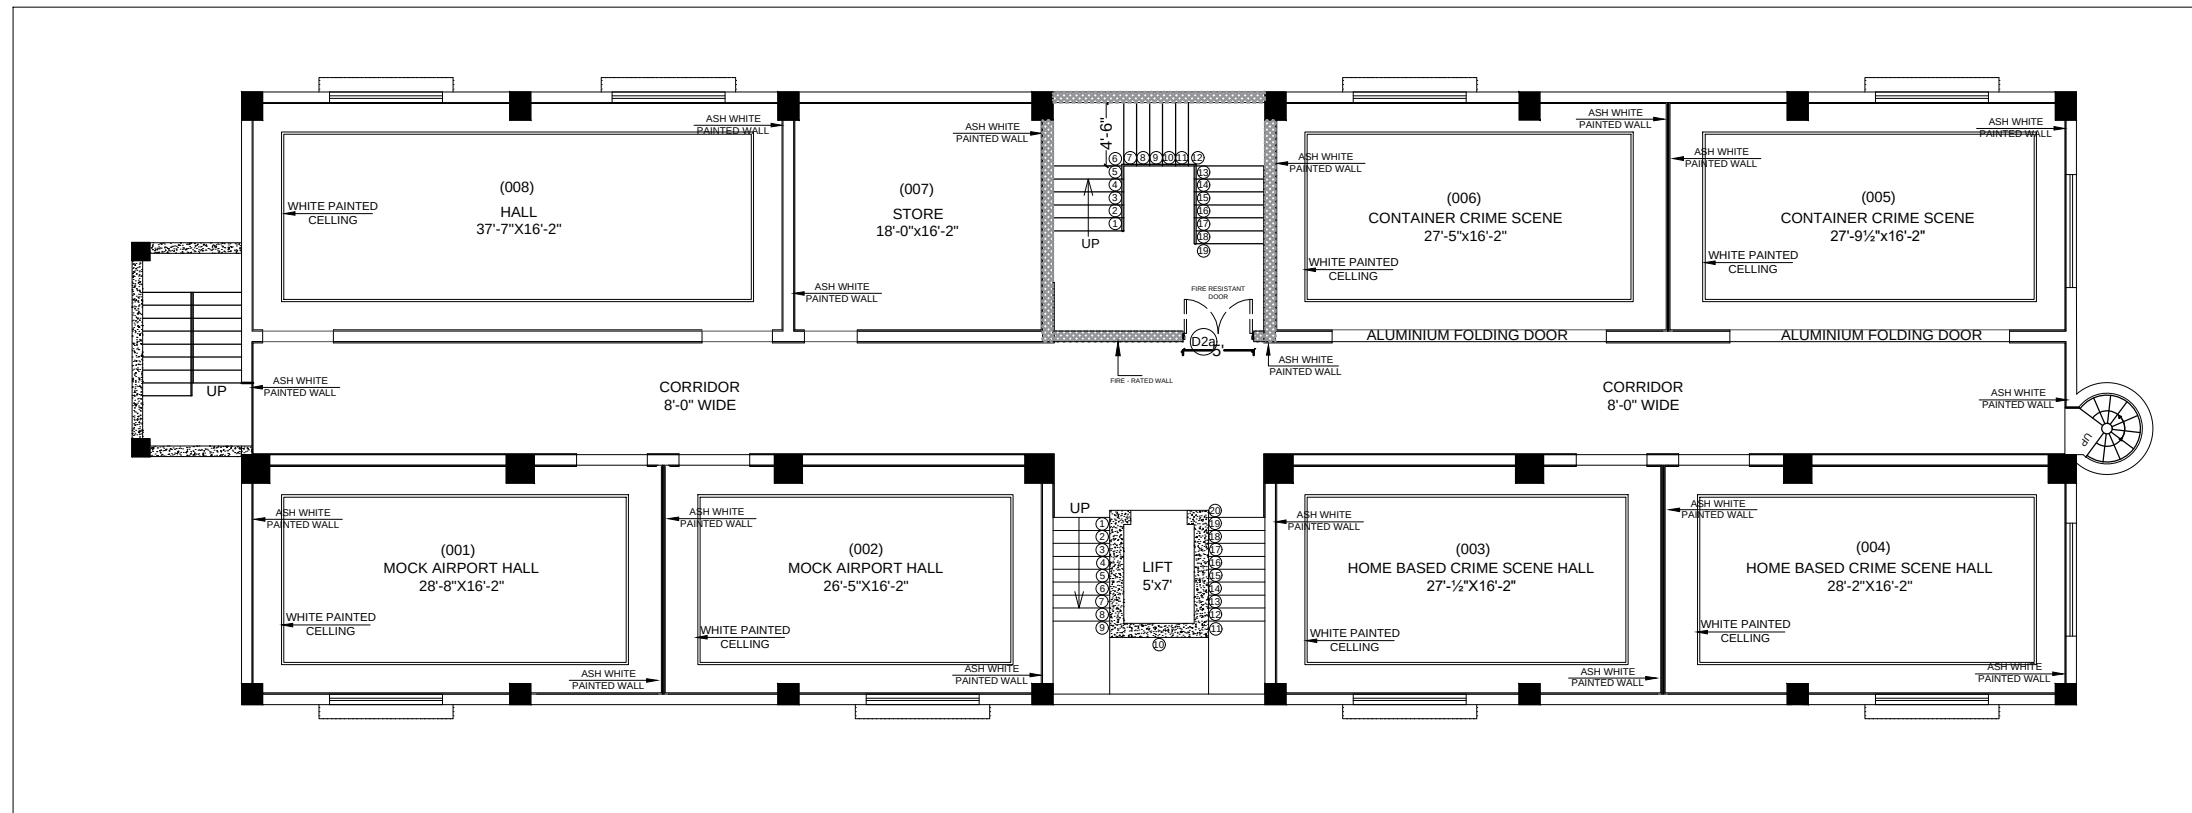

BASEMENT PLAN

Project

ANTI-NARCOTIC FORCE ACADEMY
EXTENSION AND WOMEN'S HOSTEL


Client

UNITED NATIONS DEVELOPMENT PROGRAMME

Funding Agency

INTERNATIONAL NARCOTICS AND LAW
ENFORCEMENT AFFAIRS (INL)


Consultant

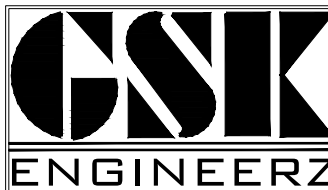

GSK ENGINEERZ
PLANNING - TESTING - DESIGNING & DEVELOPMENT
FLAT NO.205 & 206 2nd Floor, Afzal Tower Phase 3,
Main Intersection, Peshawar
Ph: +92-333-912-6118, +92-334-843-5340
E.mail: gsk.engineerz@gmail.com

SCALE : N.T.S	ARCHITECT : M.IQBAL	
SHEET NO : AR - 30	PREPARED BY : GHANI REHMAN	
DATE : AUG - 2021	DRAWING TITLE : BASEMENT PAINT DETAIL	
ARCHITECTURAL DRAWING		



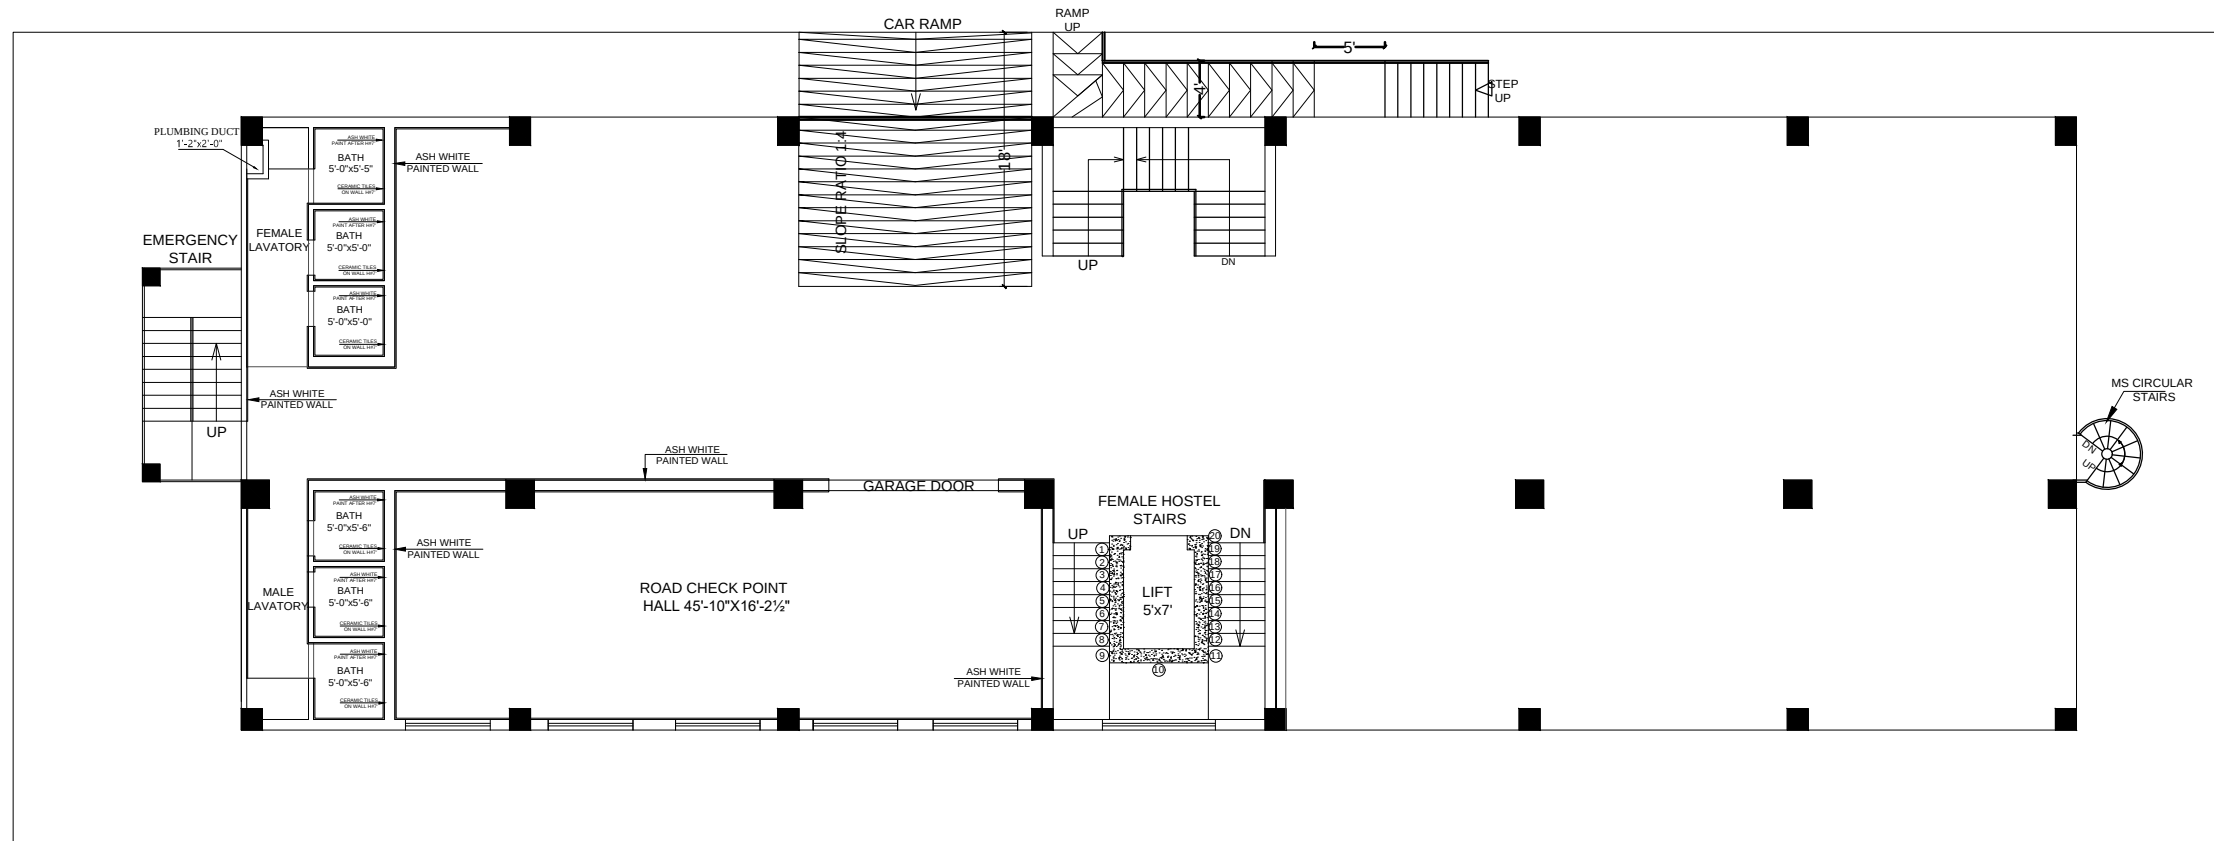

GROUND FLOOR PLAN

Project

ANTI-NARCOTIC FORCE ACADEMY
EXTENSION AND WOMEN'S HOSTEL


Client

UNITED NATIONS DEVELOPMENT PROGRAMME

Funding Agency

INTERNATIONAL NARCOTICS AND LAW
ENFORCEMENT AFFAIRS (INL)


Consultant

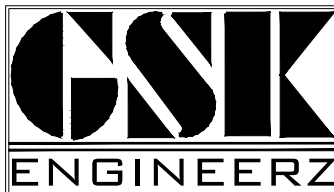

GSK ENGINEERZ
PLANNING - TESTING - DESIGNING & DEVELOPMENT
FLAT NO.205 & 206 2nd Floor, Afzal Tower Phase 3,
Main Intersection, Peshawar
Ph: +92-333-912-6118, +92-334-843-5340
E.mail: gsk-engineerz@gmail.com

SCALE : N.T.S	ARCHITECT : M.IQBAL	
SHEET NO: AR - 31	PREPARED BY : GHANI REHMAN	
DATE : AUG - 2021	DRAWING TITLE: GROUND FLOOR PAINT DETAIL	
ARCHITECTURAL DRAWING		



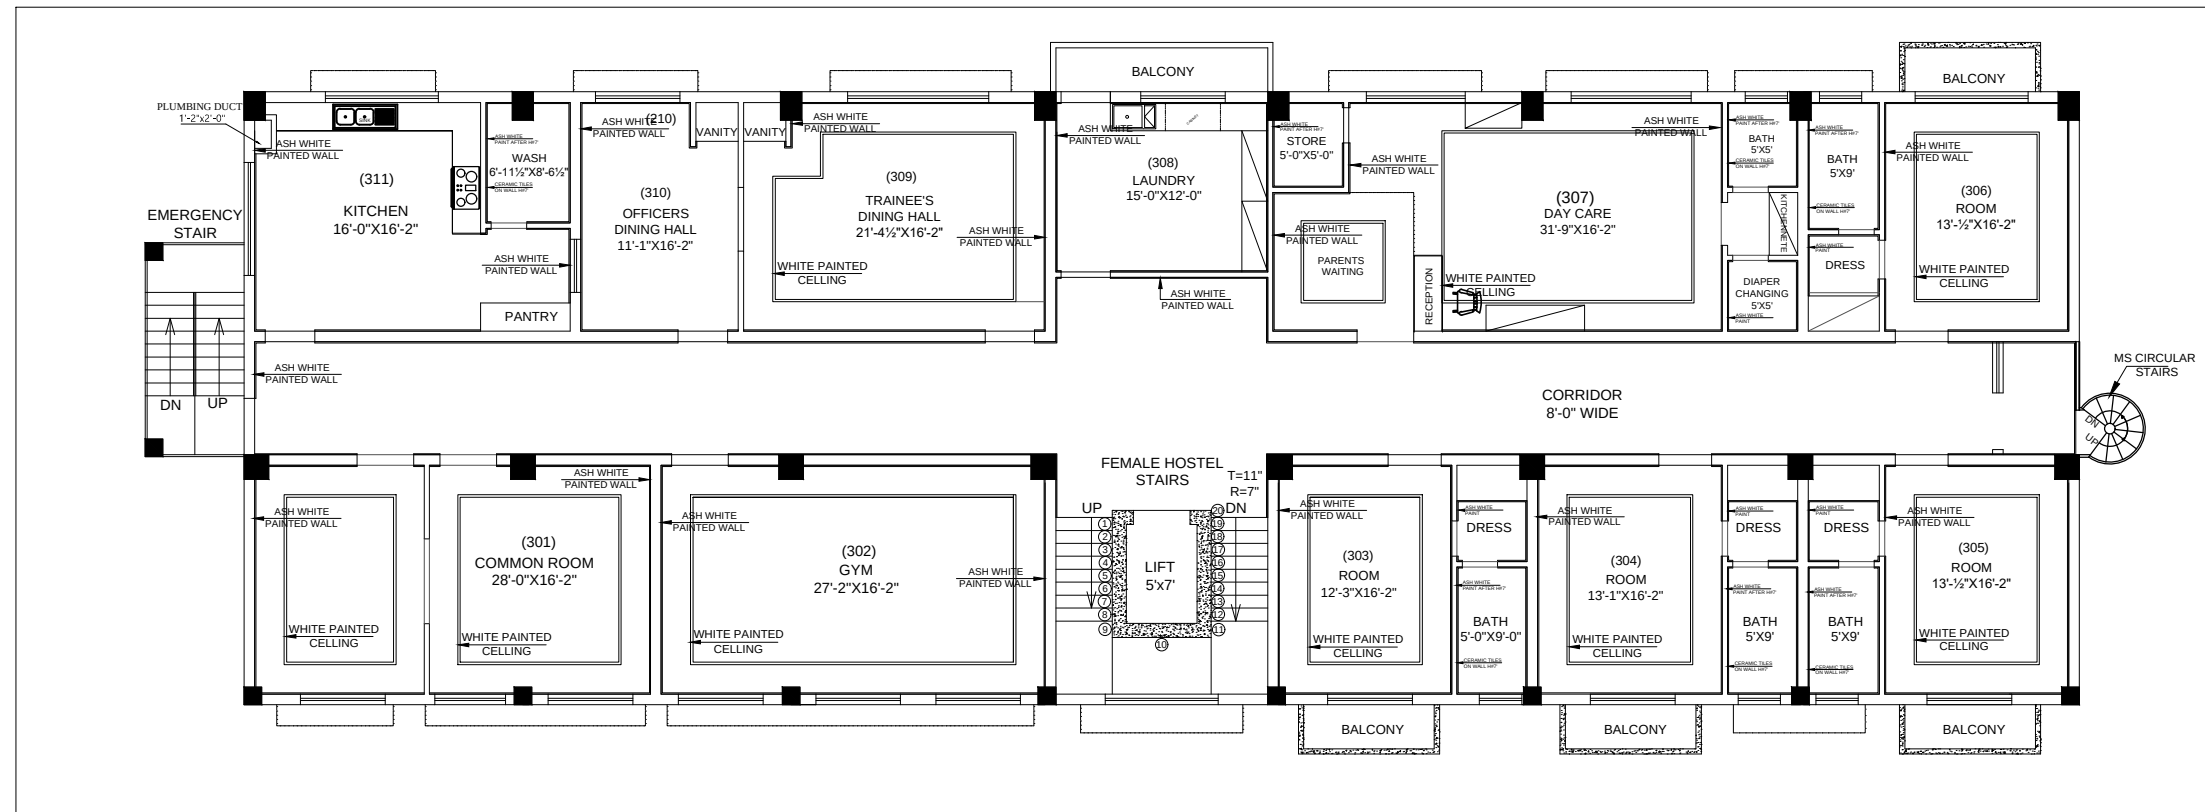

2ND FLOOR PLAN

Project

ANTI-NARCOTIC FORCE ACADEMY
EXTENSION AND WOMEN'S HOSTEL


Client

UNITED NATIONS DEVELOPMENT PROGRAMME

Funding Agency

INTERNATIONAL NARCOTICS AND LAW
ENFORCEMENT AFFAIRS (INL)

Consultant

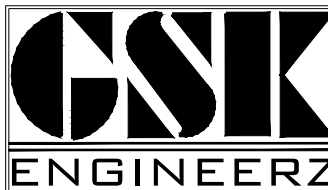

GSK ENGINEERZ
PLANNING - TESTING - DESIGNING & DEVELOPMENT
FLAT NO.205 & 206 2nd Floor, Afzal Tower Phase 3,
Main Intersection, Peshawar
Ph: +92-333-912-6118, +92-334-843-5340
E.mail: gsk-engineerz@gmail.com

SCALE :	N.T.S	ARCHITECT :	M.IQBAL
SHEET NO:	AR - 33	PREPARED BY :	GHANI REHMAN
DATE :	AUG - 2021	DRAWING TITLE:	SECOND FLOOR PAINT DETAIL
ARCHITECTURAL DRAWING			



