


PLUMBING DRAWINGS

L E G E N D		
S.NO	DESCRIPTIONS	SYMBOLS
1	4" Ø UPVC SOIL	
2	3" Ø UPVC SOIL	
3	FLOOR DRAIN	FD
4	P-TRIP	P-TRIP
5	FLOW	
6	COLD WATER PIPE	
7	HOT WATER PIPE	
8	MUSLIM SHOWER	
9	MIRROR	
10	15 LITERS ELECTRIC GEYSER	
11	MIXER TAP	
12	SOAP TRAYS	
13	PAPER HOLDERS	
14	TOWEL ROAD	
15	TRASH CAN	
16	ELECTRIC HAND DRYERS	
17	ELECTRIC WATER COOLER	
18	GREASE TRAP	
19	BURNER STOVE	
20	FIRE EXTINGUISHER ABC DRY POWDER	
21	ENGLISH TYPE W.C.	
22	WASH BASIN.	
23	SHOWER	
24	GATE VALVE	
25	WASHING SINK	
26	GATE VALVE	
27	STAINLESS STEEL GREASE TRAP	
28	FLOAT VALVE	
28	NON RETURN VALVE	



LEGEND & GENERAL NOTES

GENERAL NOTES

1. NO WORK SHALL BE CARRIED OUT UNLESS SHOP DRAWINGS ARE SUBMITTED BY THE CONTRACTOR AND APPROVED BY THE CONSULTANT.
2. CONTRACTOR SHALL COORDINATE ALL WORKS WITH ELECTRICAL, STRUCTURAL & ARCHITECTURAL DRAWINGS.
3. MECHANICAL SERVICES SHALL NOT CUT IN ANY STRUCTURAL BEAMS, RIBS OR ANY OTHER STRUCTURAL ELEMENTS UNLESS A PRIOR WRITTEN APPROVAL HAS BEEN TAKEN FROM THE ENGINEER.
4. ALL EQUIPMENTS SHALL BE INSTALLED STRICTLY AS PER MANUFACUTRER'S RECOMMENDATION.
5. MECHANICAL CONTRACTOR SHALL PROVIDE SLEEVE ON ALL PIPES PENETRATING WALLS SLABS OR BEAMS
6. ALL WORK SHALL CONFORM TO THE LATEST INTERNATIONAL BUILDING CODE, AND THE REQUIREMENTS OF LOCAL AUTHORITIES
7. MANHOLE COVERS AND FRAMES ARE TO BE HEAVY DUTY IN TRAFFIC AREAS AND MEDIUM DUTY IN PEDESTRIAN AREAS.
8. MANHOLES SHALL BE OF CONCRET CONSTRUCTION.
9. ALL UNDER GROUND SEWAGE PIPES SHALL HAVE A MINIMUM SLOPE OF 1%.
10. ALL PIPES UNDER TRAFFIC WILL HAVE MINIMUM 1000 mm COVER OR SHALL BE ENCASED IN CONCRETE
11. ALL SANITARY APPLIANCES SHALL BE PROVIDED WITH TRAPS.
12. JOINTS TO W.C. PANS SHALL BE WITH UPVC CONNECTORS & RUBBER GASKETS.
13. ISOLATING VALVES SHALL BE PROVIDED TO SEPARATE THE INDIVIDUAL TOILETS, GATE VALVES SHALL BE PROVIDED TO/ FROM WATER HEATERS
14. EXACT LOCATION OF WATER PIPE WORK SHALL BE DETERMINED ON SITE.
15. PROVIDE ISOLATING VALVE ON ALL MAIN AND BRANCH LINES FOR MAINTENANCE.
16. IN PLUMBING WATER SUPPLY SYSTEM THE PIPE DIAMETER INDICATED ARE NET FLOW AREAS (i.e. INTERNAL DIAMETERS) AND THE CONTRACTOR SHALL USE ADEQUATE PIPES SIZE, SPECIALLY WHEN USING PLASTIC PIPES TO ACCOUNT FOR PIPE WALL THICKNESS.
17. CONTRACTOR TO PROVIDE OVERFLOW, TEST PIPE, WARNING LEVEL AND DRAIN CONNECTION.
18. ALL ELECTRICAL POWER AND CONTROL WIRING/CONDUITING FROM M.C.C. TO PLUMBING EQUIPMENTS SHALL BE CARRIED OUT BY ELECTRICAL CONTRACTOR.
19. CONTRACTOR TO PROVIDE CLEAN OUTS AT EVERY 15 METER OF PIPE RUN EVEN IF IT IS NOT MENTIONED IN THE DRAWINGS.
20. FOR COLD WATER SUPPLY PPR PN-20 PIPES SHALL BE USED.
21. ALL EXPOSED COLD AND HOT WATER PIPING SHALL BE PPR.
22. ALL HOT WATER PIPES SHALL BE PPR PN-20.
23. ALL HOT WATER PIPES SHALL BE INSULATED.
24. PPR PIPE INTERNAL CLEAR DIA.

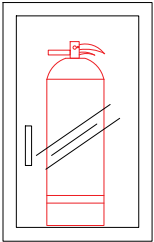

FIRE EXTINGUISHER CABINET DETAIL

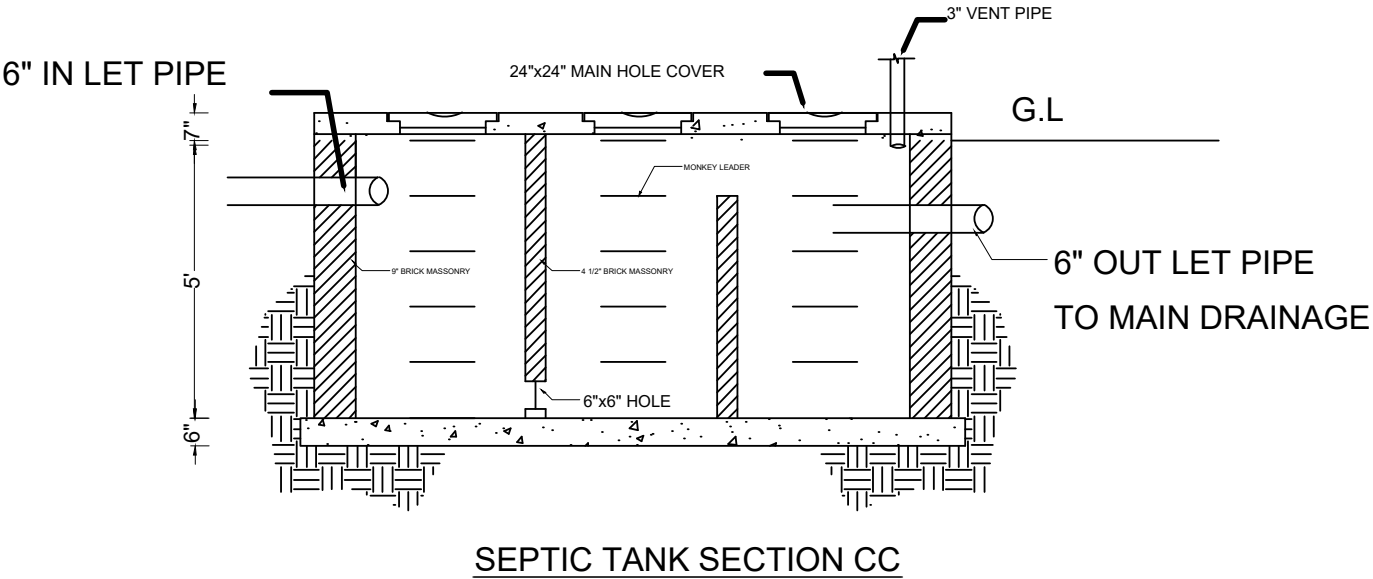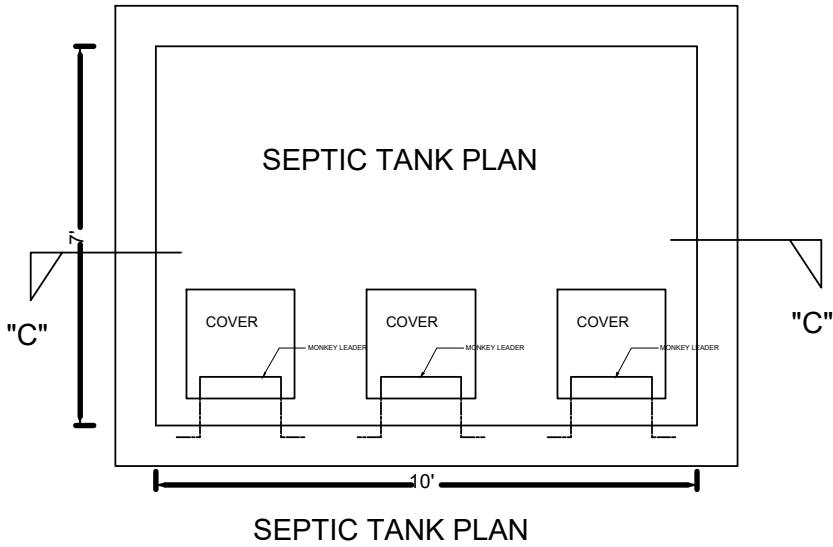

Project

ANTI-NARCOTIC FORCE ACADEMY
EXTENSION AND WOMEN'S HOSTEL

Client

UNITED NATIONS DEVELOPMENT PROGRAMME

Funding Agency

INTERNATIONAL NARCOTICS AND LAW
ENFORCEMENT AFFAIRS (INL)


Consultant


GSK

ENGINEERZ

PLANNING - TESTING - DESIGNING & DEVELOPMENT
FLAT NO 205 & 206 2nd Floor, Atzal Tower Phase 3,
Main Intersection, Peshawar
Ph: +92-333-912-6118, +92-334-843-5340
E.mail: gsk.engineerz@gmail.com

SCALE : N.T.S	ARCHITECT : ASAD HASSAN
SHEET NO : PL - 01	PREPARED BY : GHANI REHMAN
DATE : AUG - 2021	DRAWING TITLE : LEGEND AND SEPTIK TANK
PLUMBING DRAWING	

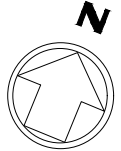

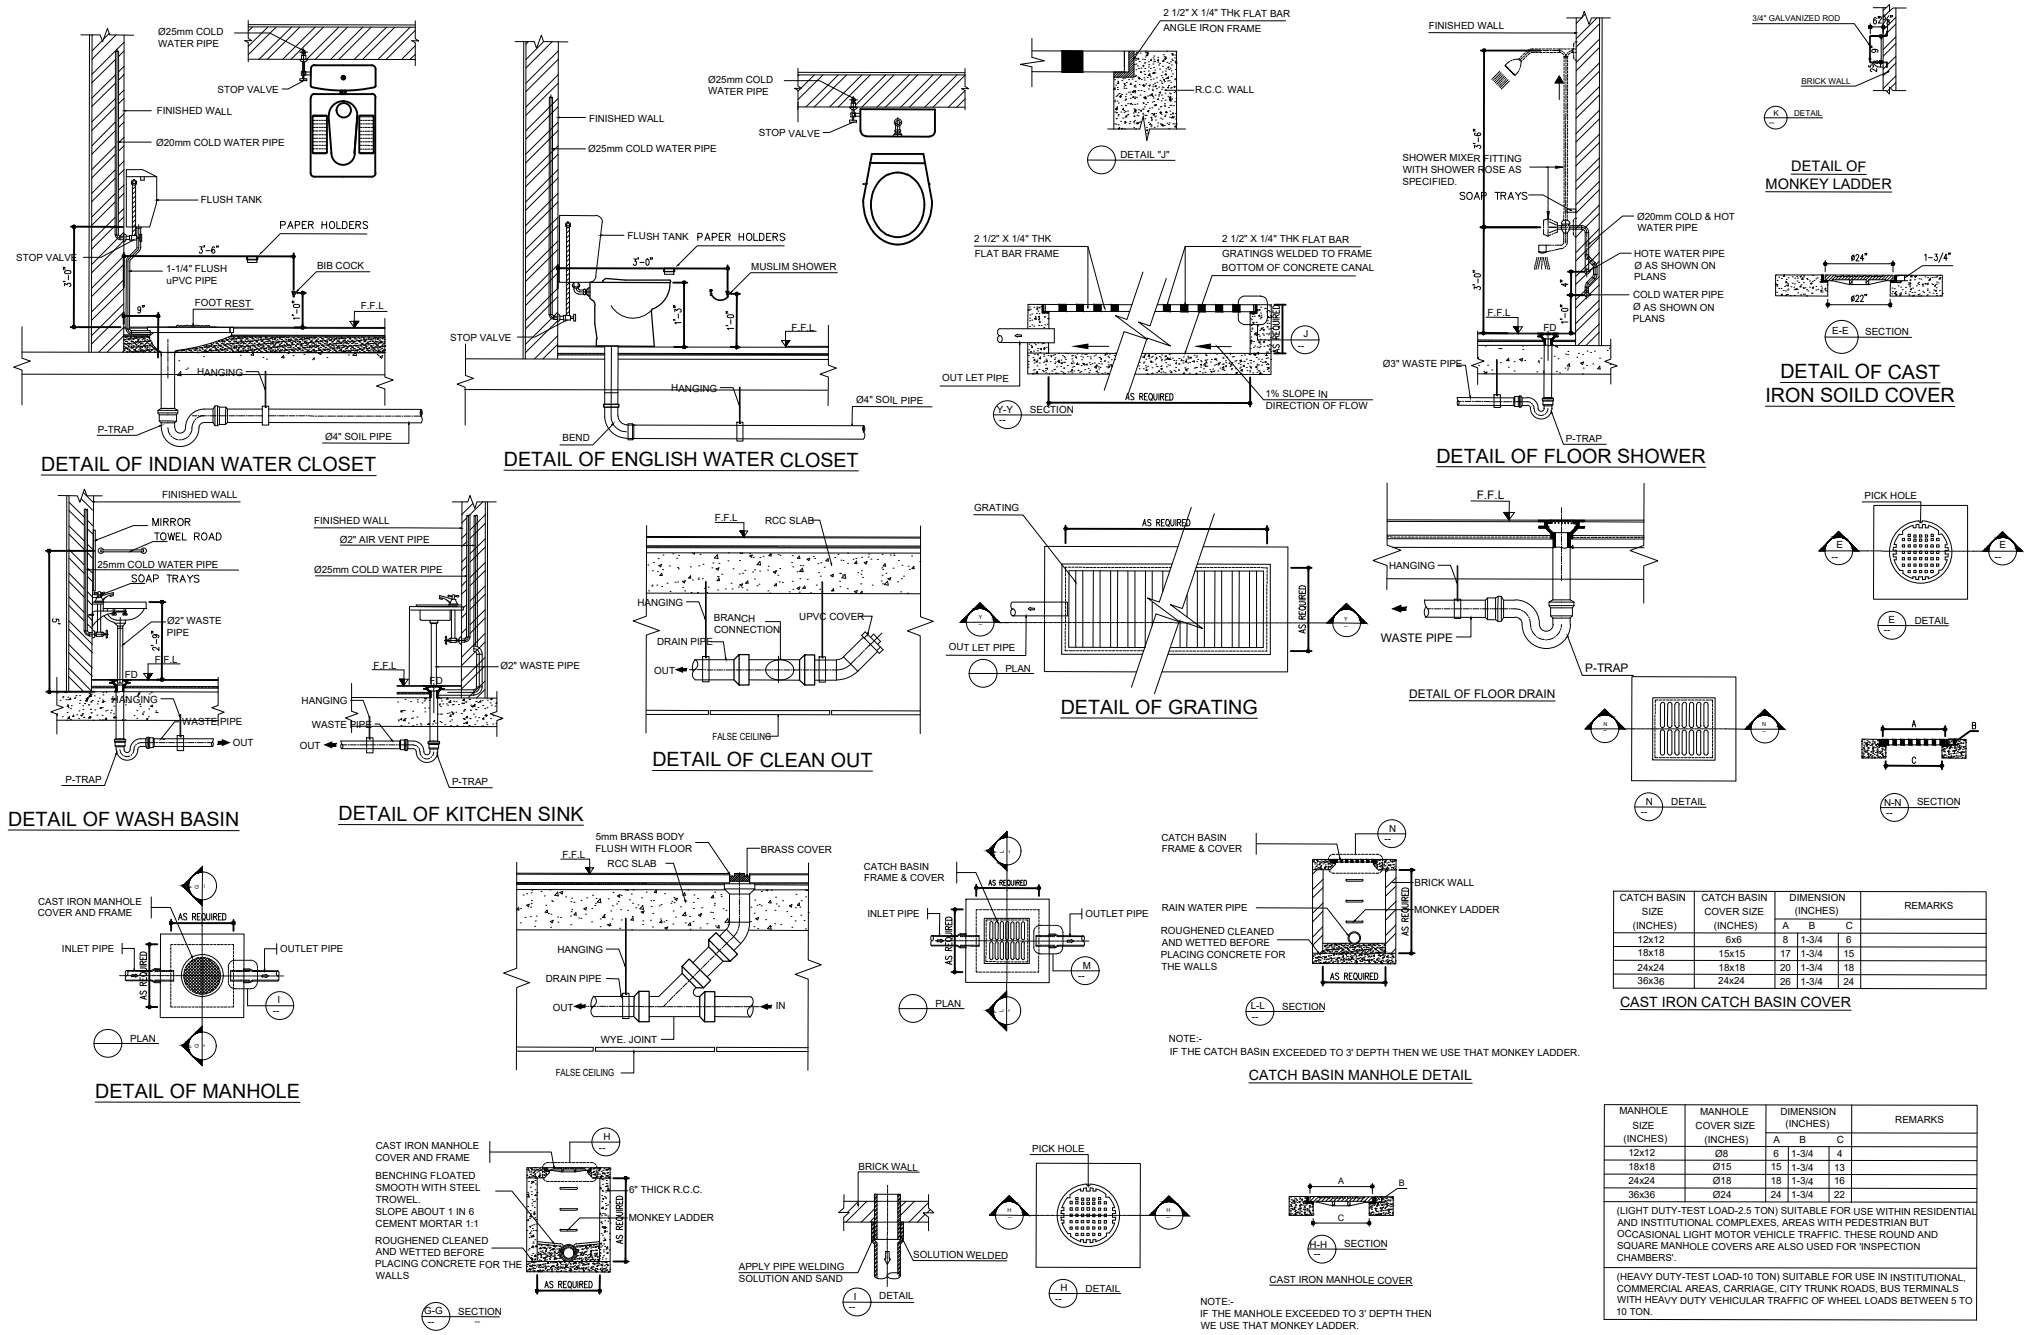

Project

ANTI-NARCOTIC FORCE ACADEMY
EXTENSION AND WOMEN'S HOSTEL

Client


UNITED NATIONS DEVELOPMENT PROGRAMME
Funding Agency
INTERNATIONAL NARCOTICS AND LAW
ENFORCEMENT AFFAIRS (INL)


Consultant

GSK
ENGINEERZ

GSK ENGINEERZ
PLANNING - TESTING - DESIGNING & DEVELOPMENT
FLAT NO 205 & 206 2nd Floor, Atzal Tower Phase 3,
Main Intersection, Peshawar
Ph: +92-333-912-6118, +92-334-843-5340
E-mail: gsk.engineerz@gmail.com

SCALE : N.T.S	ARCHITECT : ASAD HASSAN	
SHEET NO : PL - 02	PREPARED BY : GHANI REHMAN	
DATE : AUG - 2021	DRAWING TITLE : PLUMBING AND BLOW UP DETAIL	
PLUMBING DRAWING		

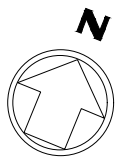

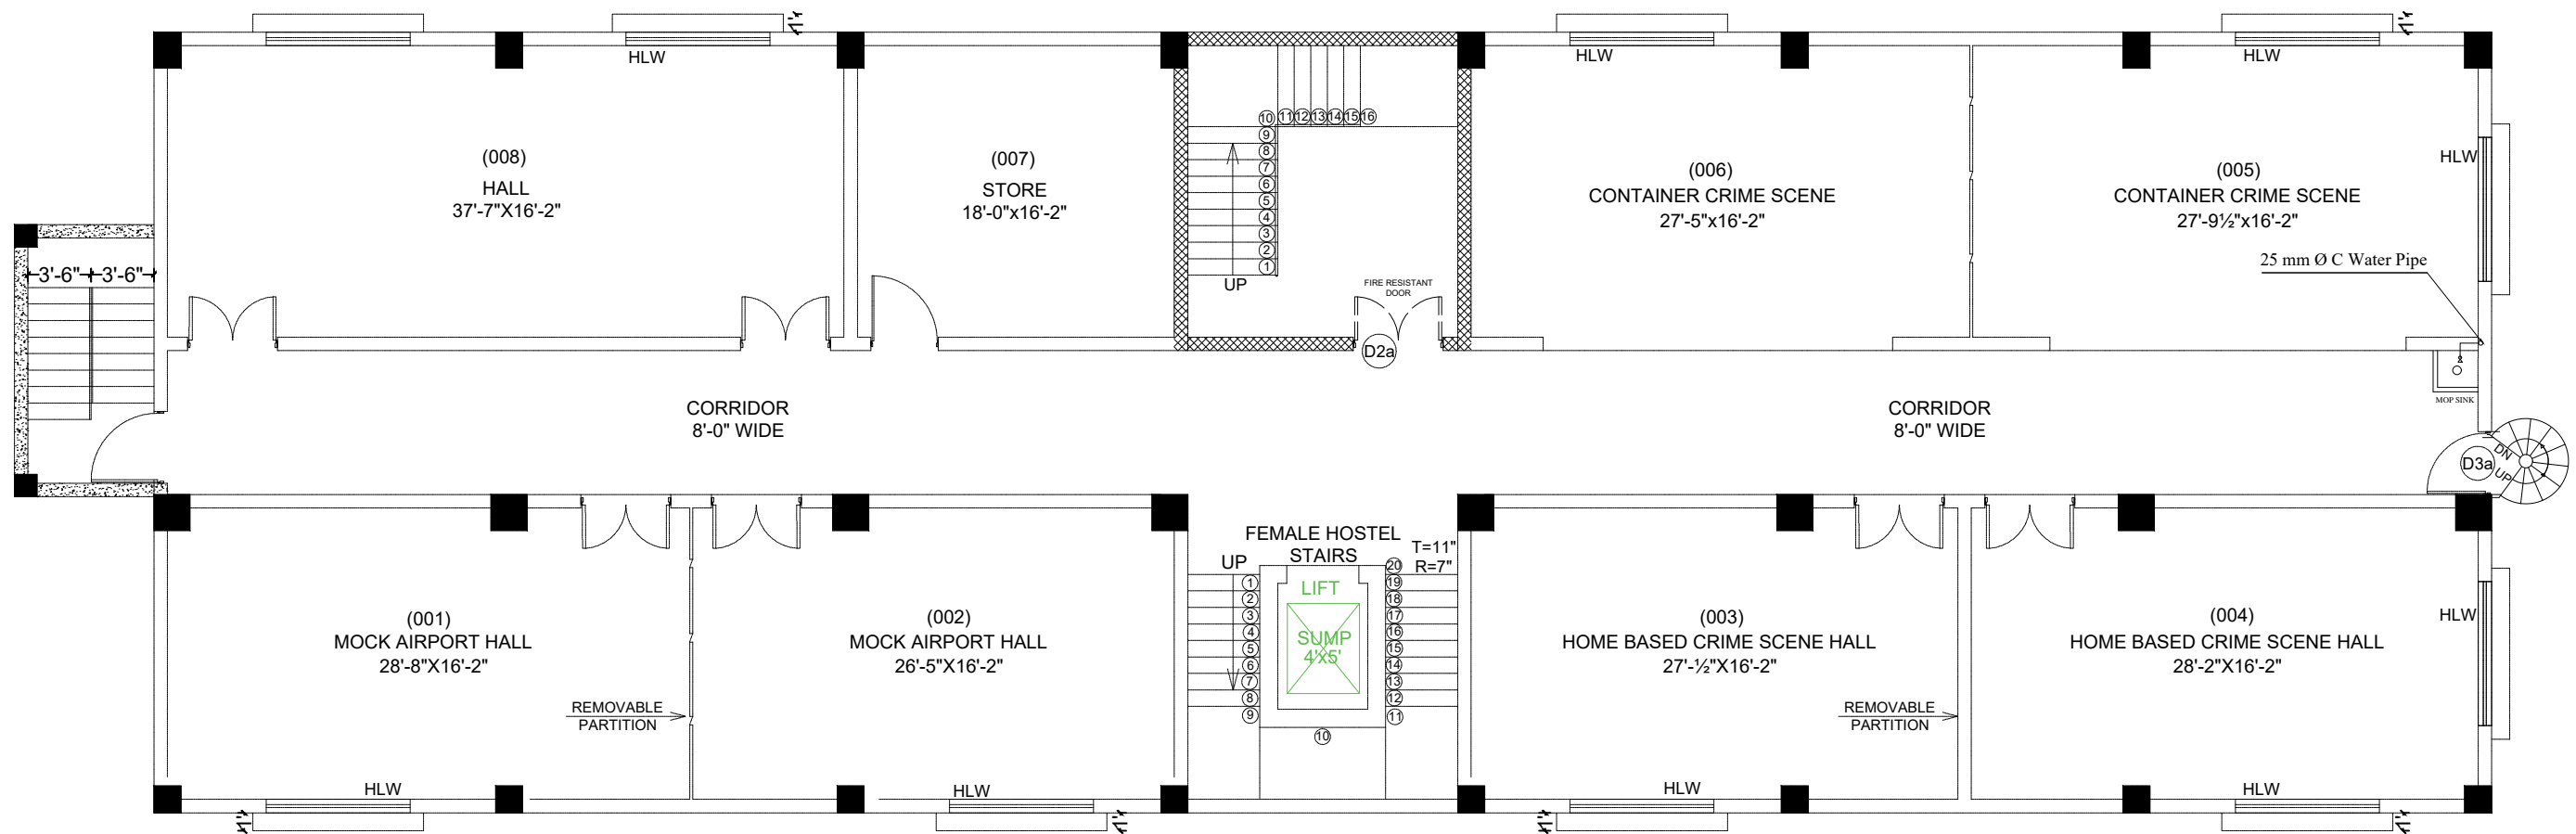

BASEMENT PLAN


Project

ANTI-NARCOTIC FORCE ACADEMY
EXTENSION AND WOMEN'S HOSTEL

Client


UNITED NATIONS DEVELOPMENT PROGRAMME
Funding Agency
INTERNATIONAL NARCOTICS AND LAW
ENFORCEMENT AFFAIRS (INL)


Consultant

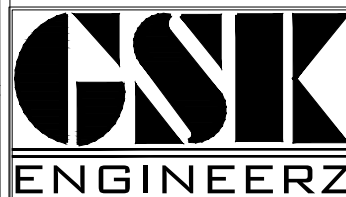

GSK ENGINEERZ
PLANNING - TESTING - DESIGNING & DEVELOPMENT
FLAT NO.205 & 206 2nd Floor, Afzal Tower Phase 3,
Main Intersection, Peshawar
Ph: +92-333-912-6118, +92-334-843-5340
E-mail: gsk.engineerz@gmail.com

SCALE : N.T.S	ARCHITECT : ASAD HASSAN
SHEET NO : PL - 03	PREPARED BY : GHANI REHMAN
DATE : AUG - 2021	DRAWING TITLE : BASEMENT FLOOR WATER SUPPLY
PLUMBING DRAWING	

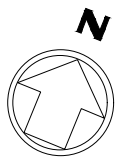

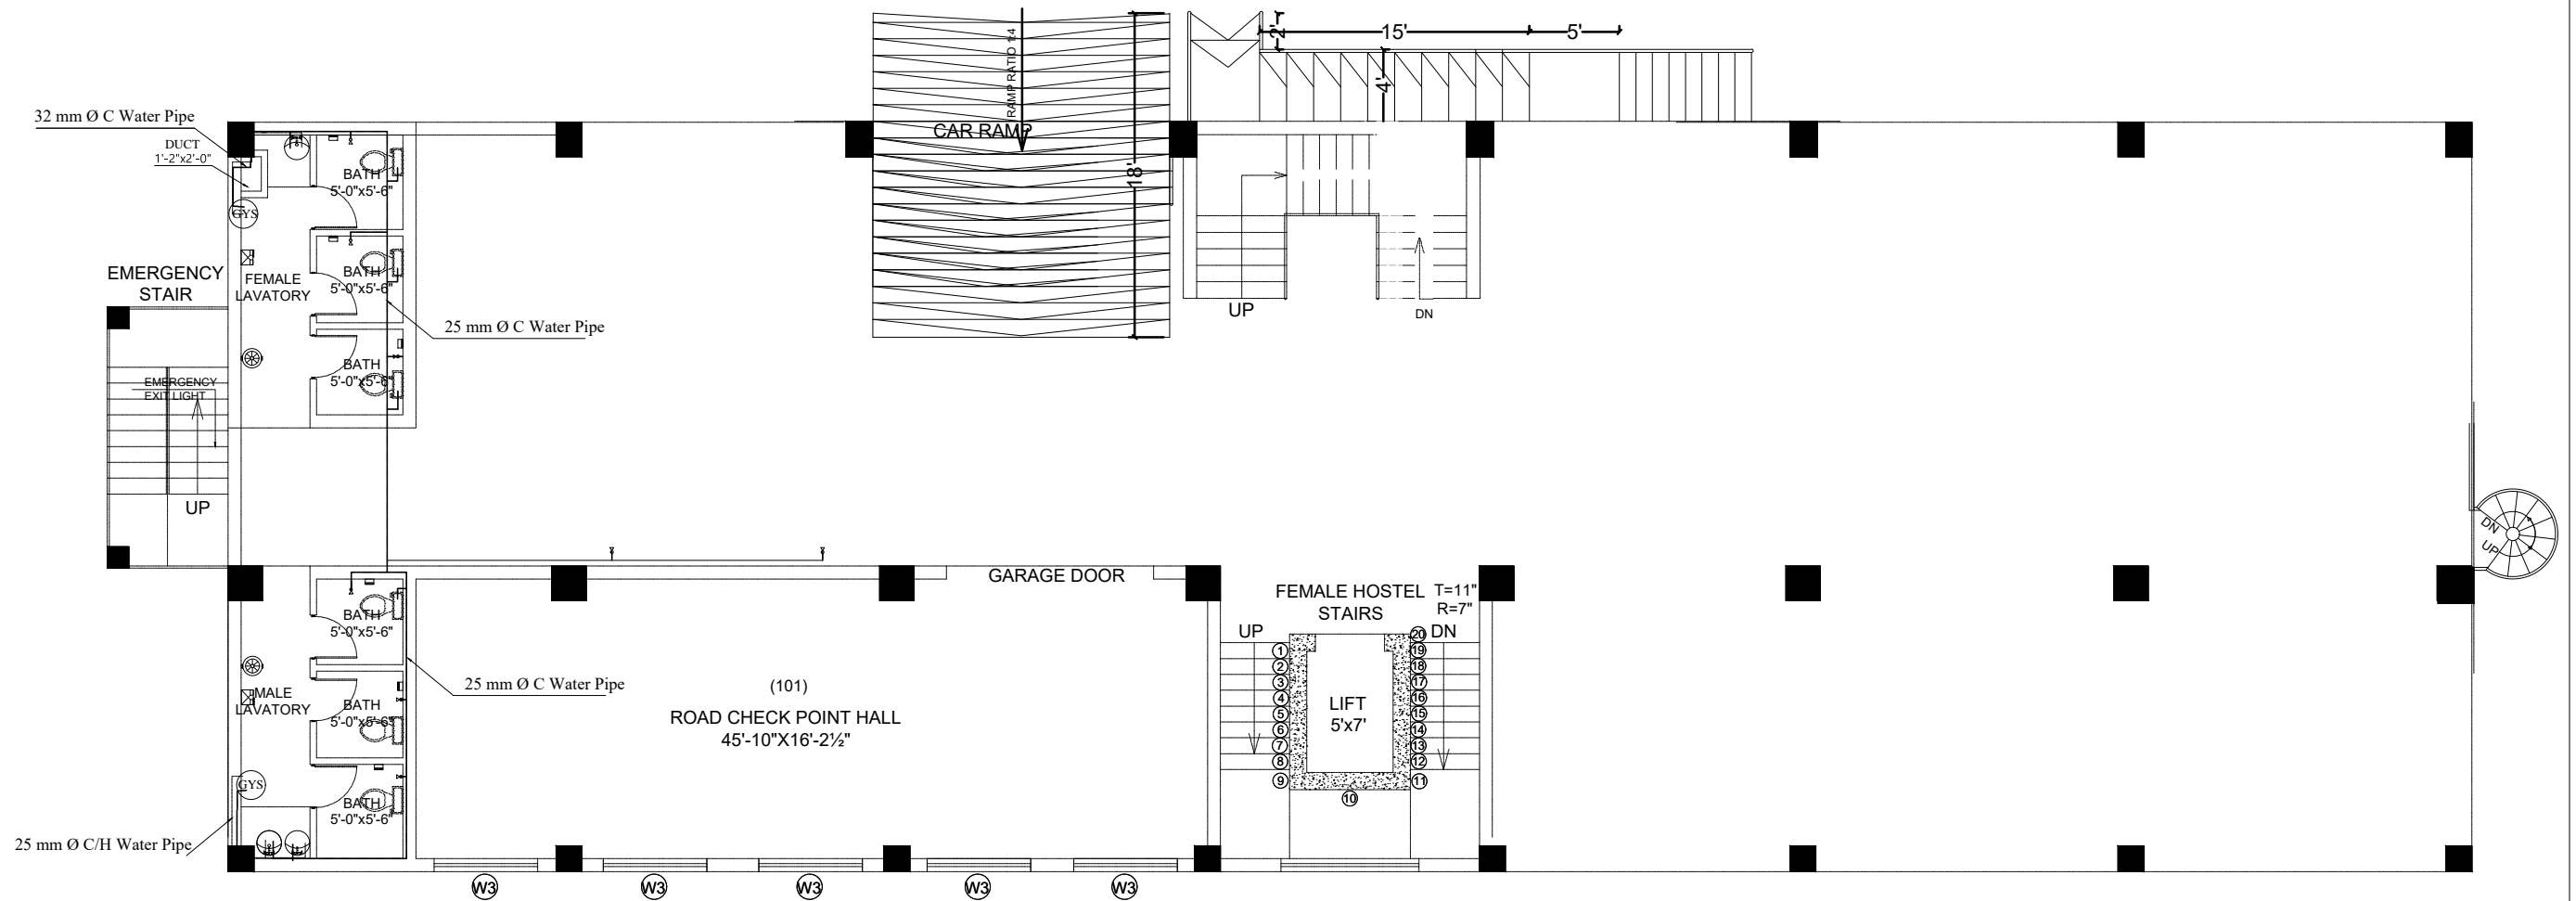

GROUND FLOOR PLAN

Project

ANTI-NARCOTIC FORCE ACADEMY
EXTENSION AND WOMEN'S HOSTEL


Client

UNITED NATIONS DEVELOPMENT PROGRAMME

Funding Agency

INTERNATIONAL NARCOTICS AND LAW
ENFORCEMENT AFFAIRS (INL)


Consultant

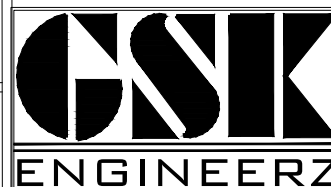


GSK ENGINEERZ

PLANNING - TESTING - DESIGNING & DEVELOPMENT
FLAT NO.205 & 206 2nd Floor, Atzal Tower Phase 3,
Main Intersection, Peshawar
Ph: +92-333-912-6118, +92-334-843-5340
E-mail: gsk.engineerz@gmail.com

SCALE: N.T.S	ARCHITECT: ASAD HASSAN
SHEET NO: PL - 04	PREPARED BY: GHANI REHMAN
DATE: AUG - 2021	DRAWING TITLE: GROUND FLOOR WATER SUPPLY
PLUMBING DRAWING	

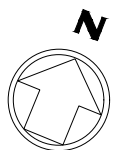

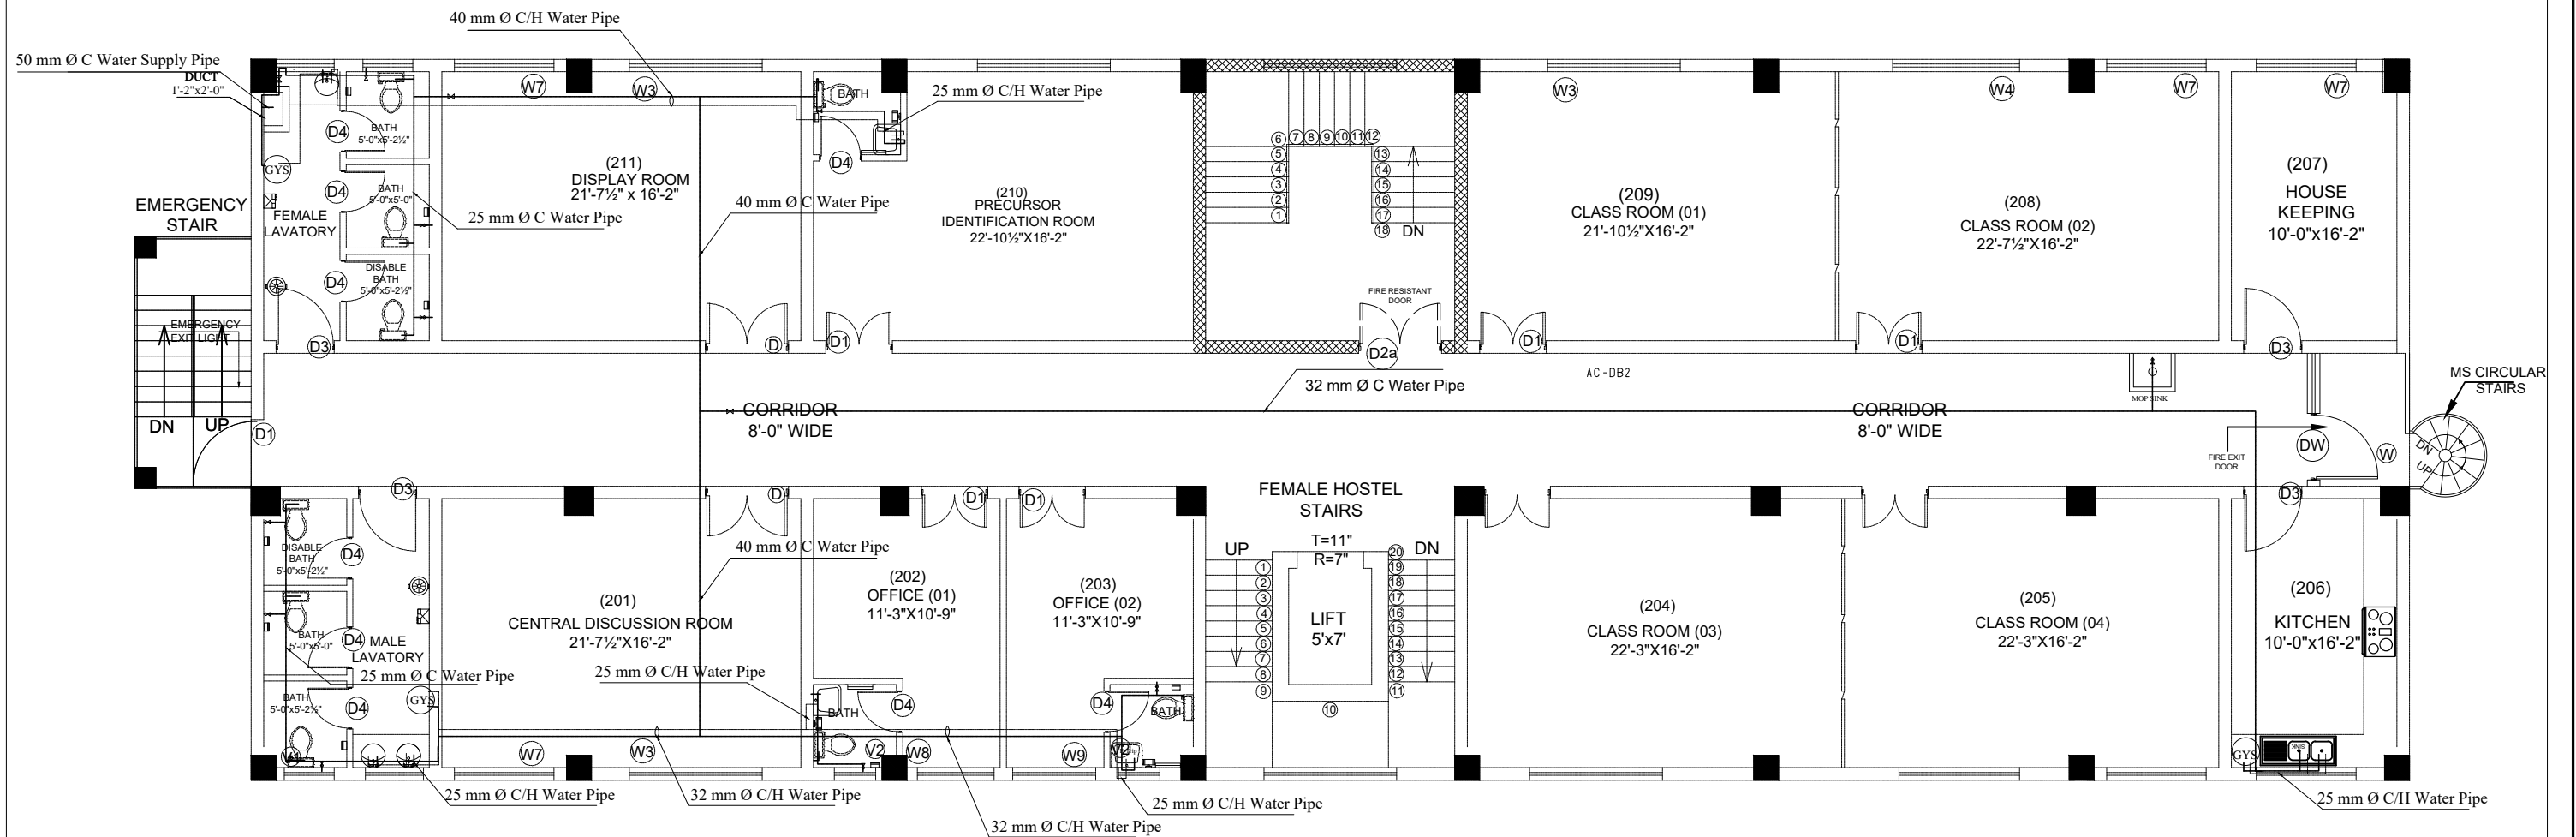

FIRST FLOOR PLAN

Project

ANTI-NARCOTIC FORCE ACADEMY
EXTENSION AND WOMEN'S HOSTEL


Client

UNITED NATIONS DEVELOPMENT PROGRAMME

Funding Agency

INTERNATIONAL NARCOTICS AND LAW
ENFORCEMENT AFFAIRS (INL)


Consultant

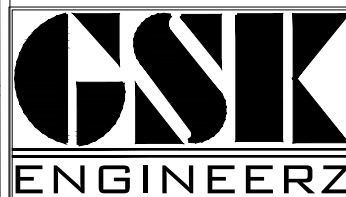


GSK ENGINEERZ

PLANNING - TESTING - DESIGNING & DEVELOPMENT
FLAT NO.205 & 206 2nd Floor, Afzal Tower Phase 3,
Main Intersection, Peshawar
Ph: +92-333-912-6118, +92-334-843-5340
E-mail: gsk.engineerz@gmail.com

SCALE :	N.T.S	ARCHITECT :	ASAD HASSAN
SHEET NO :	PL - 05	PREPARED BY :	GHANI REHMAN
DATE :	AUG - 2021	DRAWING TITLE :	FIRST FLOOR WATER SUPPLY
PLUMBING DRAWING			

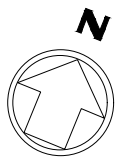

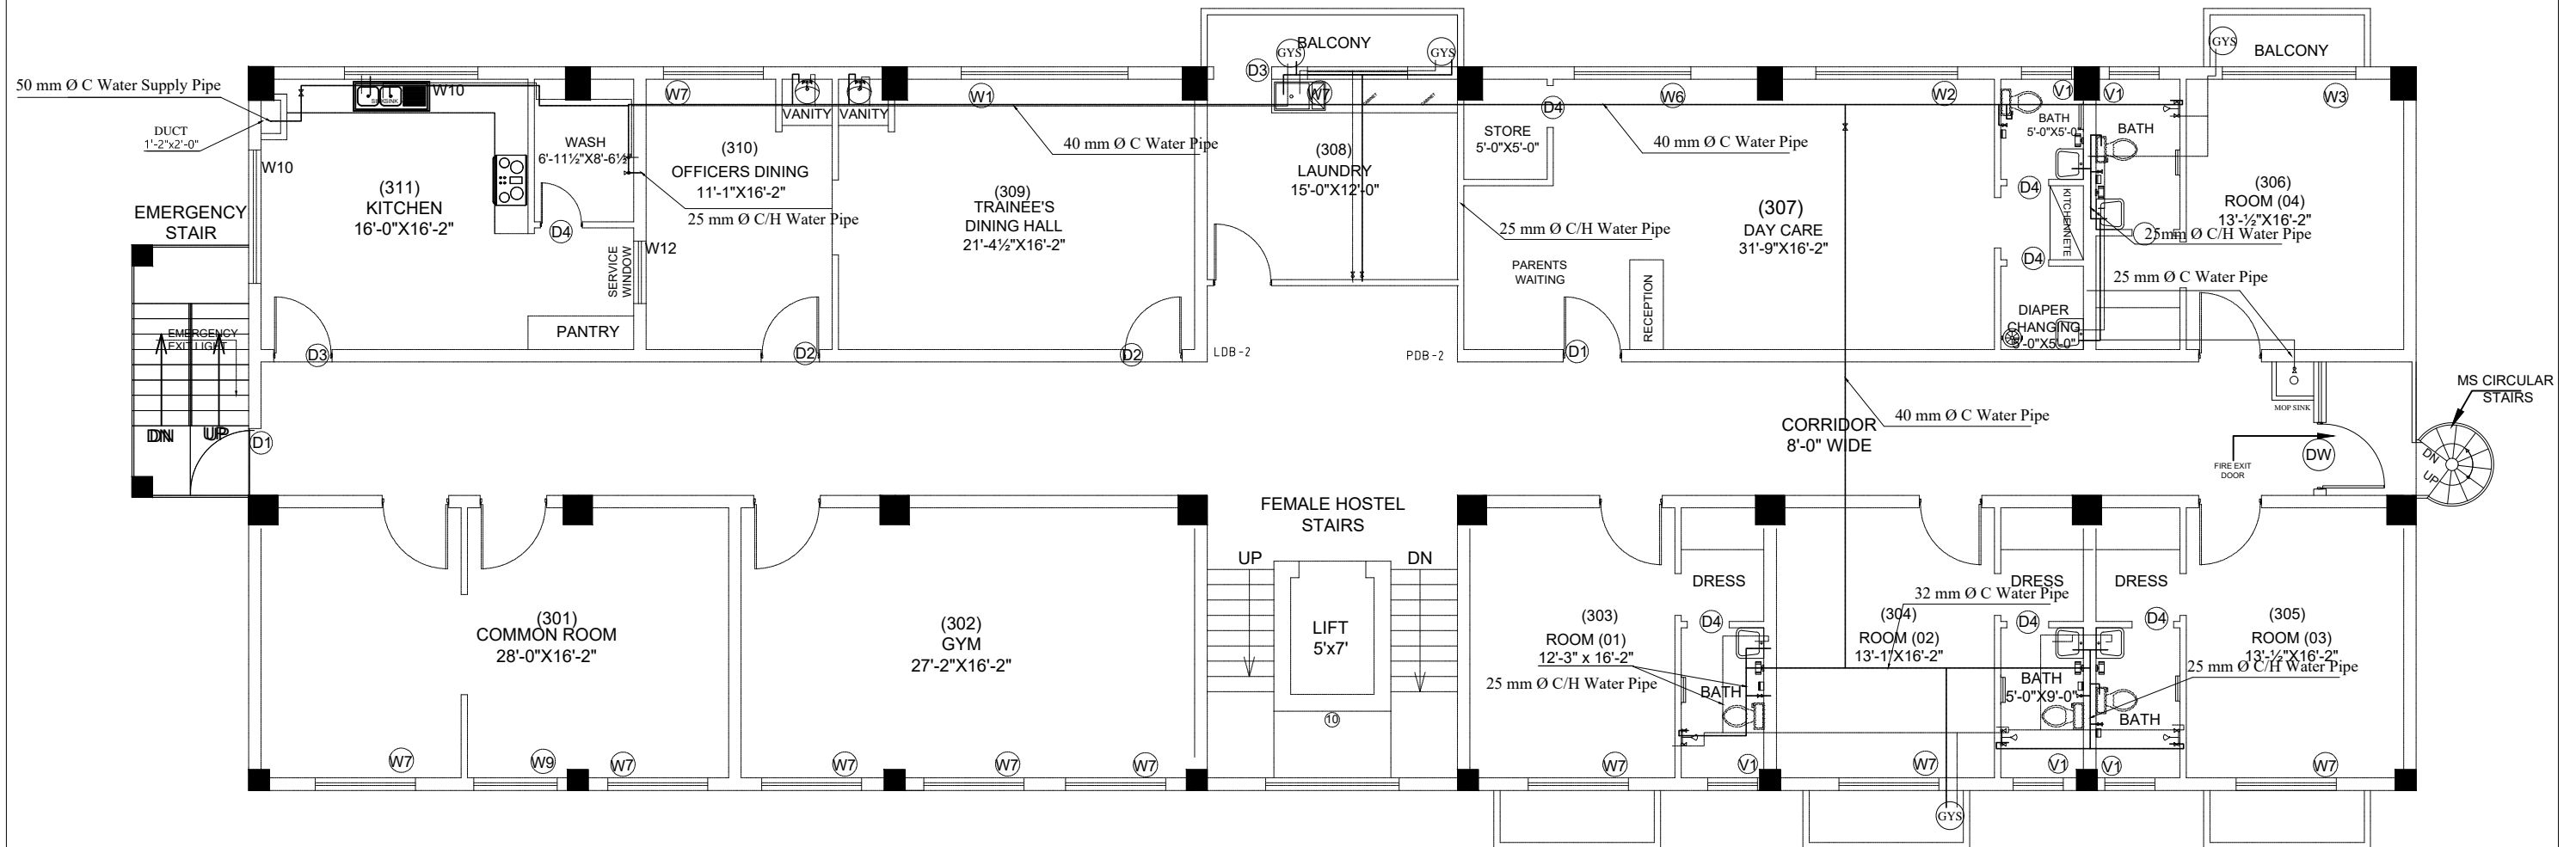

2ND FLOOR PLAN

Project

ANTI-NARCOTIC FORCE ACADEMY
EXTENSION AND WOMEN'S HOSTEL

Client

UNITED NATIONS DEVELOPMENT PROGRAMME

Funding Agency

INTERNATIONAL NARCOTICS AND LAW
ENFORCEMENT AFFAIRS (INL)


Consultant

GSK
ENGINEERZ

GSK ENGINEERZ
PLANNING - TESTING - DESIGNING & DEVELOPMENT
FLAT NO.205 & 206 2nd Floor, Afzal Tower Phase 3,
Main Intersection, Peshawar
Ph: +92-333-912-6118, +92-334-843-5340
E-mail: gsk.engineerz@gmail.com

SCALE :	N.T.S	ARCHITECT :	ASAD HASSAN
SHEET NO :	PL - 06	PREPARED BY :	GHANI REHMAN
DATE :	AUG - 2021	DRAWING TITLE :	2ND FLOOR WATER SUPPLY
PLUMBING DRAWING			



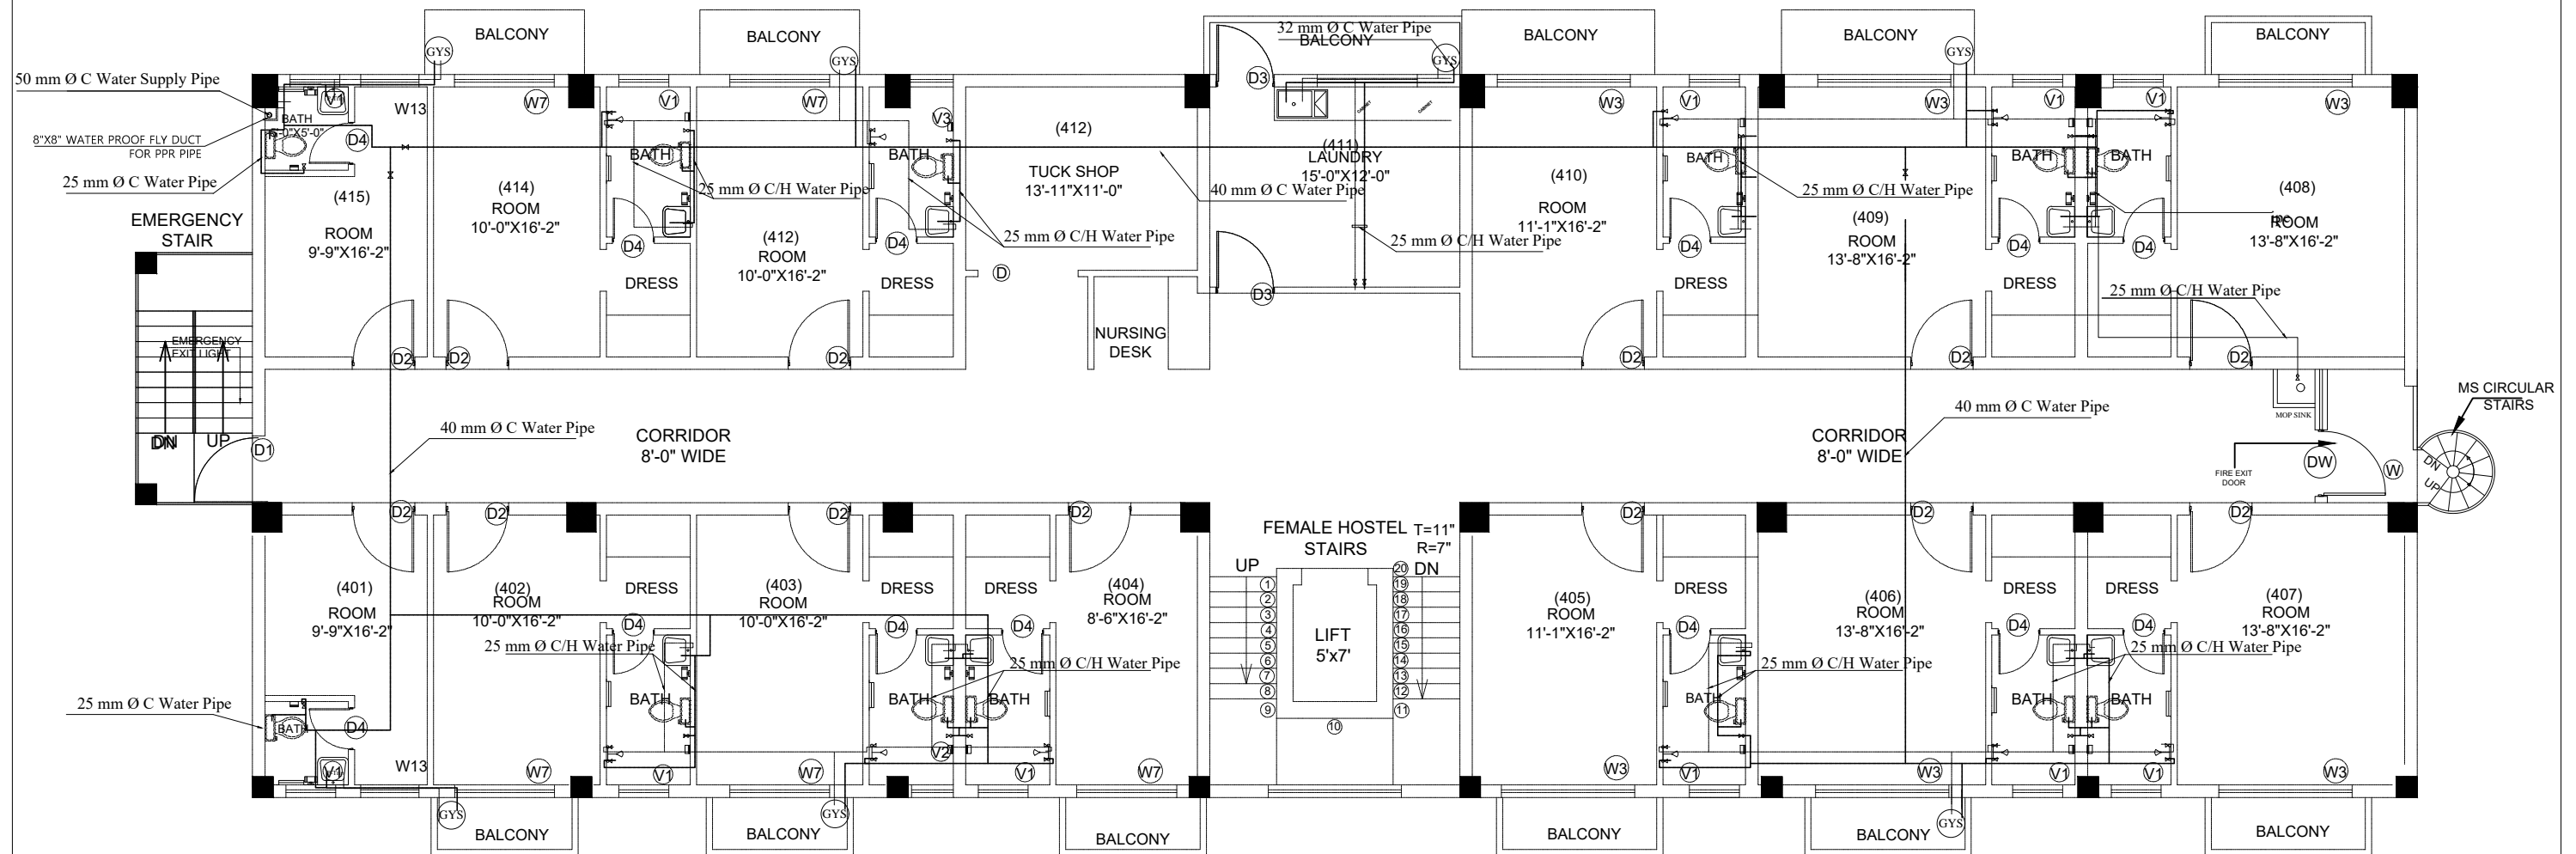

3RD FLOOR PLAN

Project

ANTI-NARCOTIC FORCE ACADEMY
EXTENSION AND WOMEN'S HOSTEL


Client

UNITED NATIONS DEVELOPMENT PROGRAMME

Funding Agency

INTERNATIONAL NARCOTICS AND LAW
ENFORCEMENT AFFAIRS (INL)


Consultant

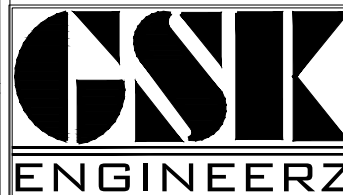


GSK ENGINEERZ

PLANNING - TESTING - DESIGNING & DEVELOPMENT
FLAT NO.205 & 206 2nd Floor, Afzal Tower Phase 3,
Main Intersection, Peshawar
Ph: +92-333-912-6118, +92-334-843-5340
E-mail: gsk.engineerz@gmail.com

SCALE :	N.T.S	ARCHITECT :	ASAD HASSAN
SHEET NO :	PL - 07	PREPARED BY :	GHANI REHMAN
DATE :	AUG - 2021	DRAWING TITLE :	3RD FLOOR WATER SUPPLY
PLUMBING DRAWING			

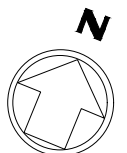

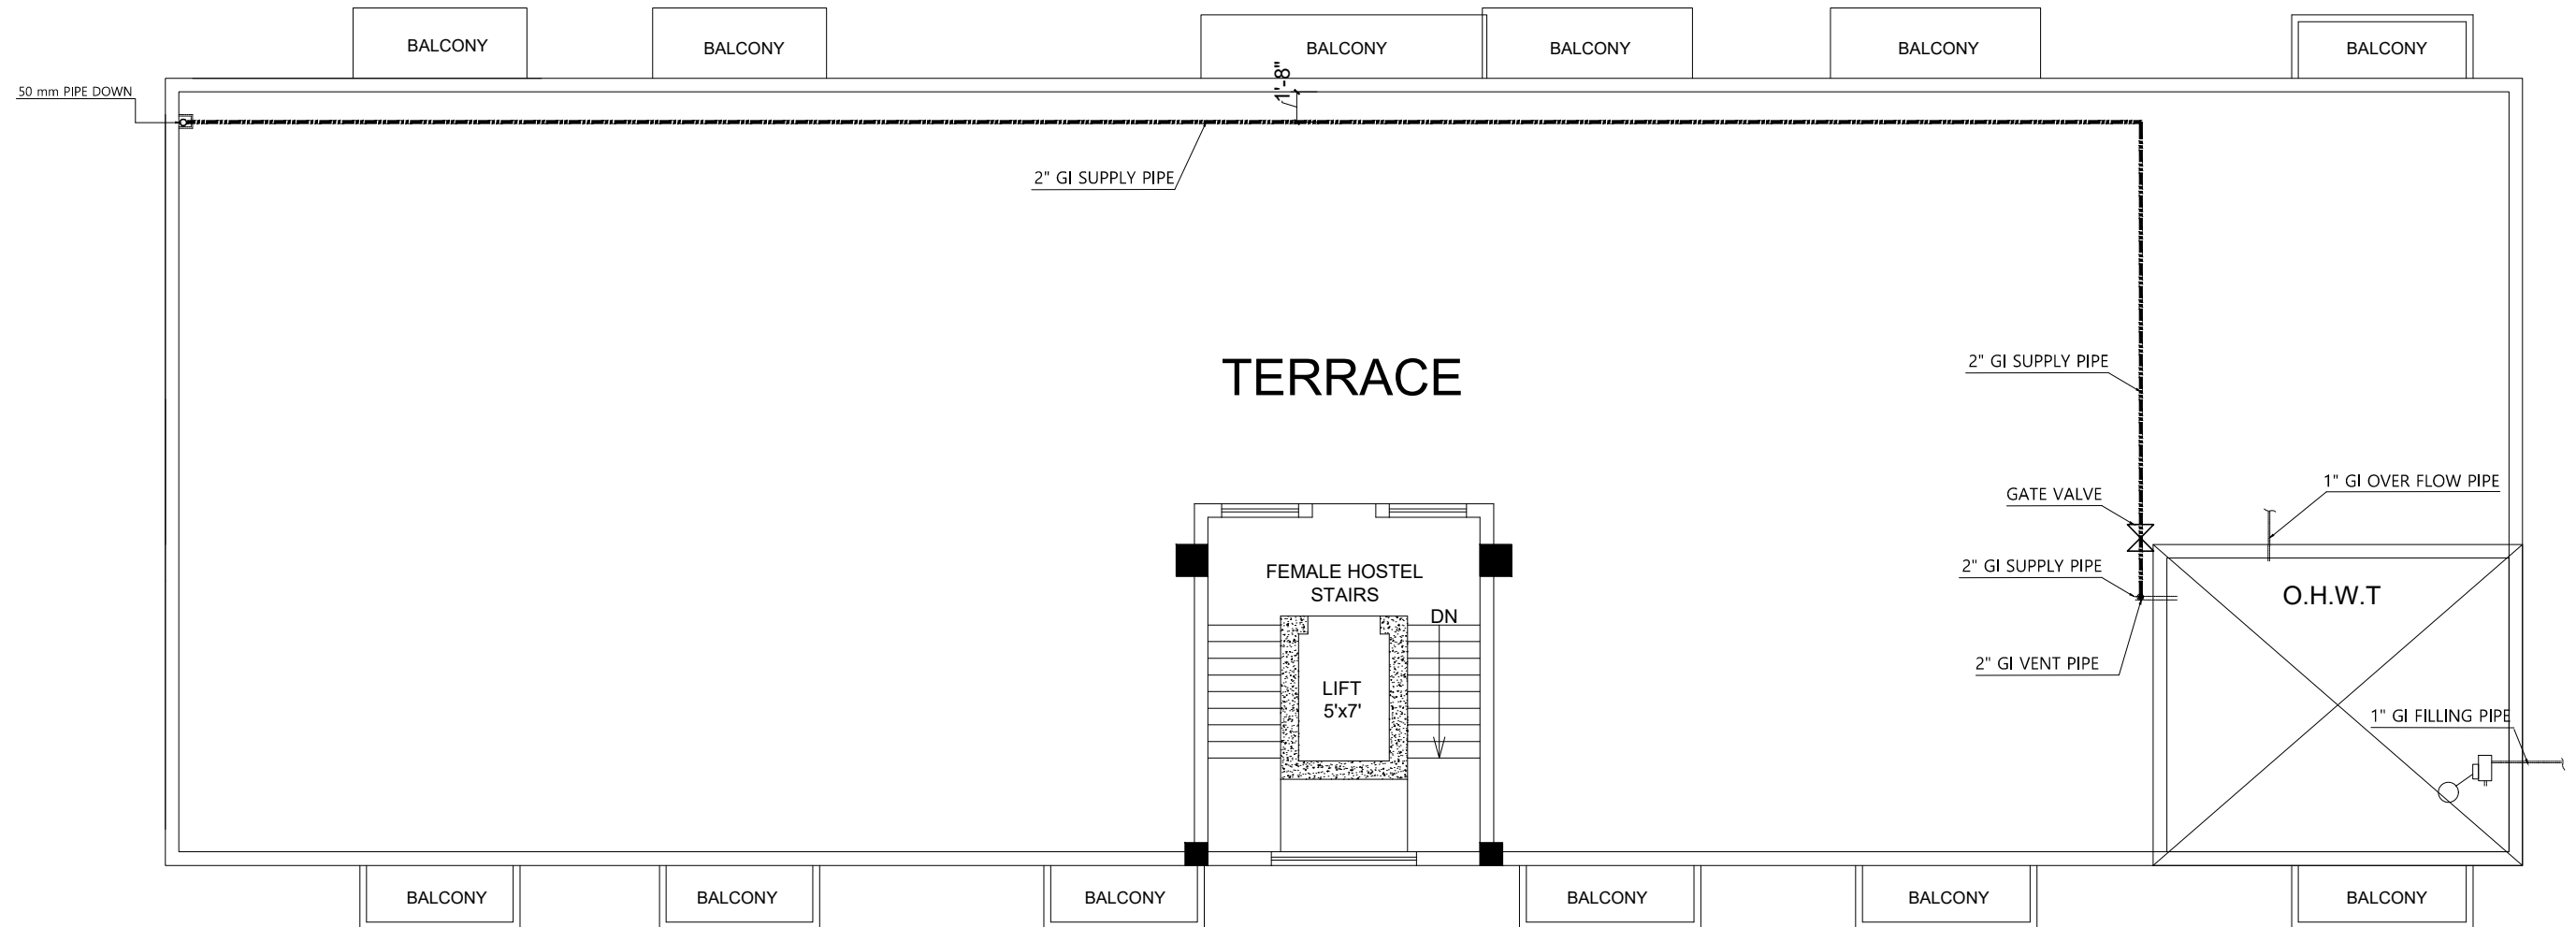

TOP ROOF PLAN

Project

ANTI-NARCOTIC FORCE ACADEMY
EXTENSION AND WOMEN'S HOSTEL

Client

UNITED NATIONS DEVELOPMENT PROGRAMME

Funding Agency


INTERNATIONAL NARCOTICS AND LAW
ENFORCEMENT AFFAIRS (INL)


Consultant

GSK
ENGINEERZ

GSK ENGINEERZ
PLANNING - TESTING - DESIGNING & DEVELOPMENT
FLAT NO.205 & 206 2nd Floor, Afzal Tower Phase 3,
Main Intersection, Peshawar
Ph: +92-333-912-6118, +92-334-843-5340
E-mail: gsk.engineerz@gmail.com

SCALE : N.T.S	ARCHITECT : ASAD HASSAN
SHEET NO: PL - 08	PREPARED BY : GHANI REHMAN
DATE : AUG - 2021	DRAWING TITLE: ROOF TOP WATER SUPPLY
PLUMBING DRAWING	

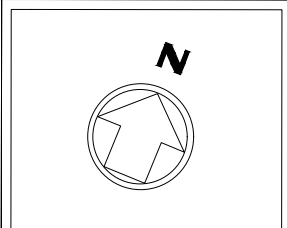

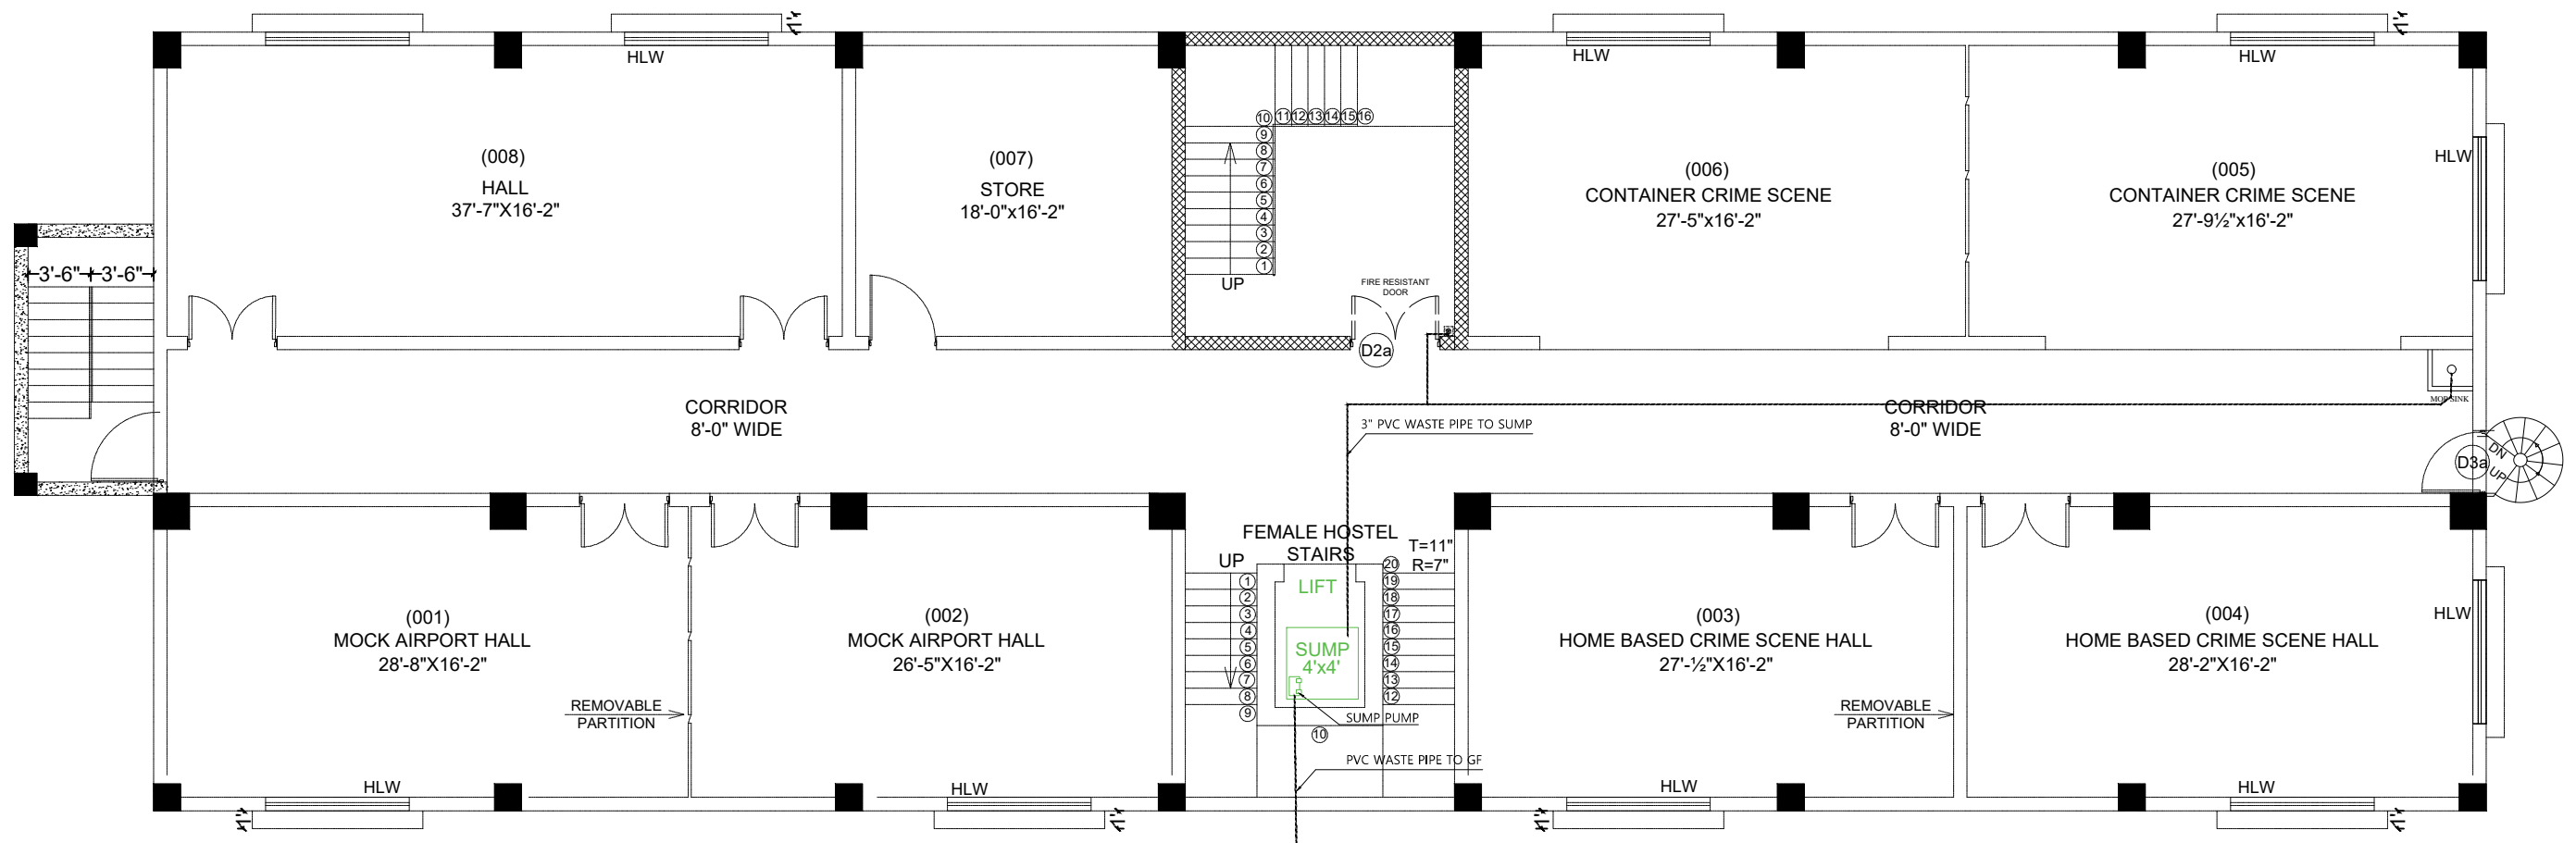

BASEMENT PLAN

Project

ANTI-NARCOTIC FORCE ACADEMY
EXTENSION AND WOMEN'S HOSTEL

Client

UNITED NATIONS DEVELOPMENT PROGRAMME

Funding Agency


INTERNATIONAL NARCOTICS AND LAW
ENFORCEMENT AFFAIRS (INL)


Consultant

GSK
ENGINEERZ

GSK ENGINEERZ
PLANNING - TESTING - DESIGNING & DEVELOPMENT
FLAT NO.205 & 206 2nd Floor, Afzal Tower Phase 3,
Main Intersection, Peshawar
Ph: +92-333-912-6118, +92-334-843-5340
Email: gsk.engineerz@gmail.com

SCALE : N.T.S	ARCHITECT : ASAD HASSAN
SHEET NO : PL - 10	PREPARED BY : GHANI REHMAN
DATE : AUG - 2021	DRAWING TITLE : BASEMENT FLOOR DRAINAGE
PLUMBING DRAWING	

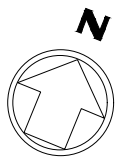

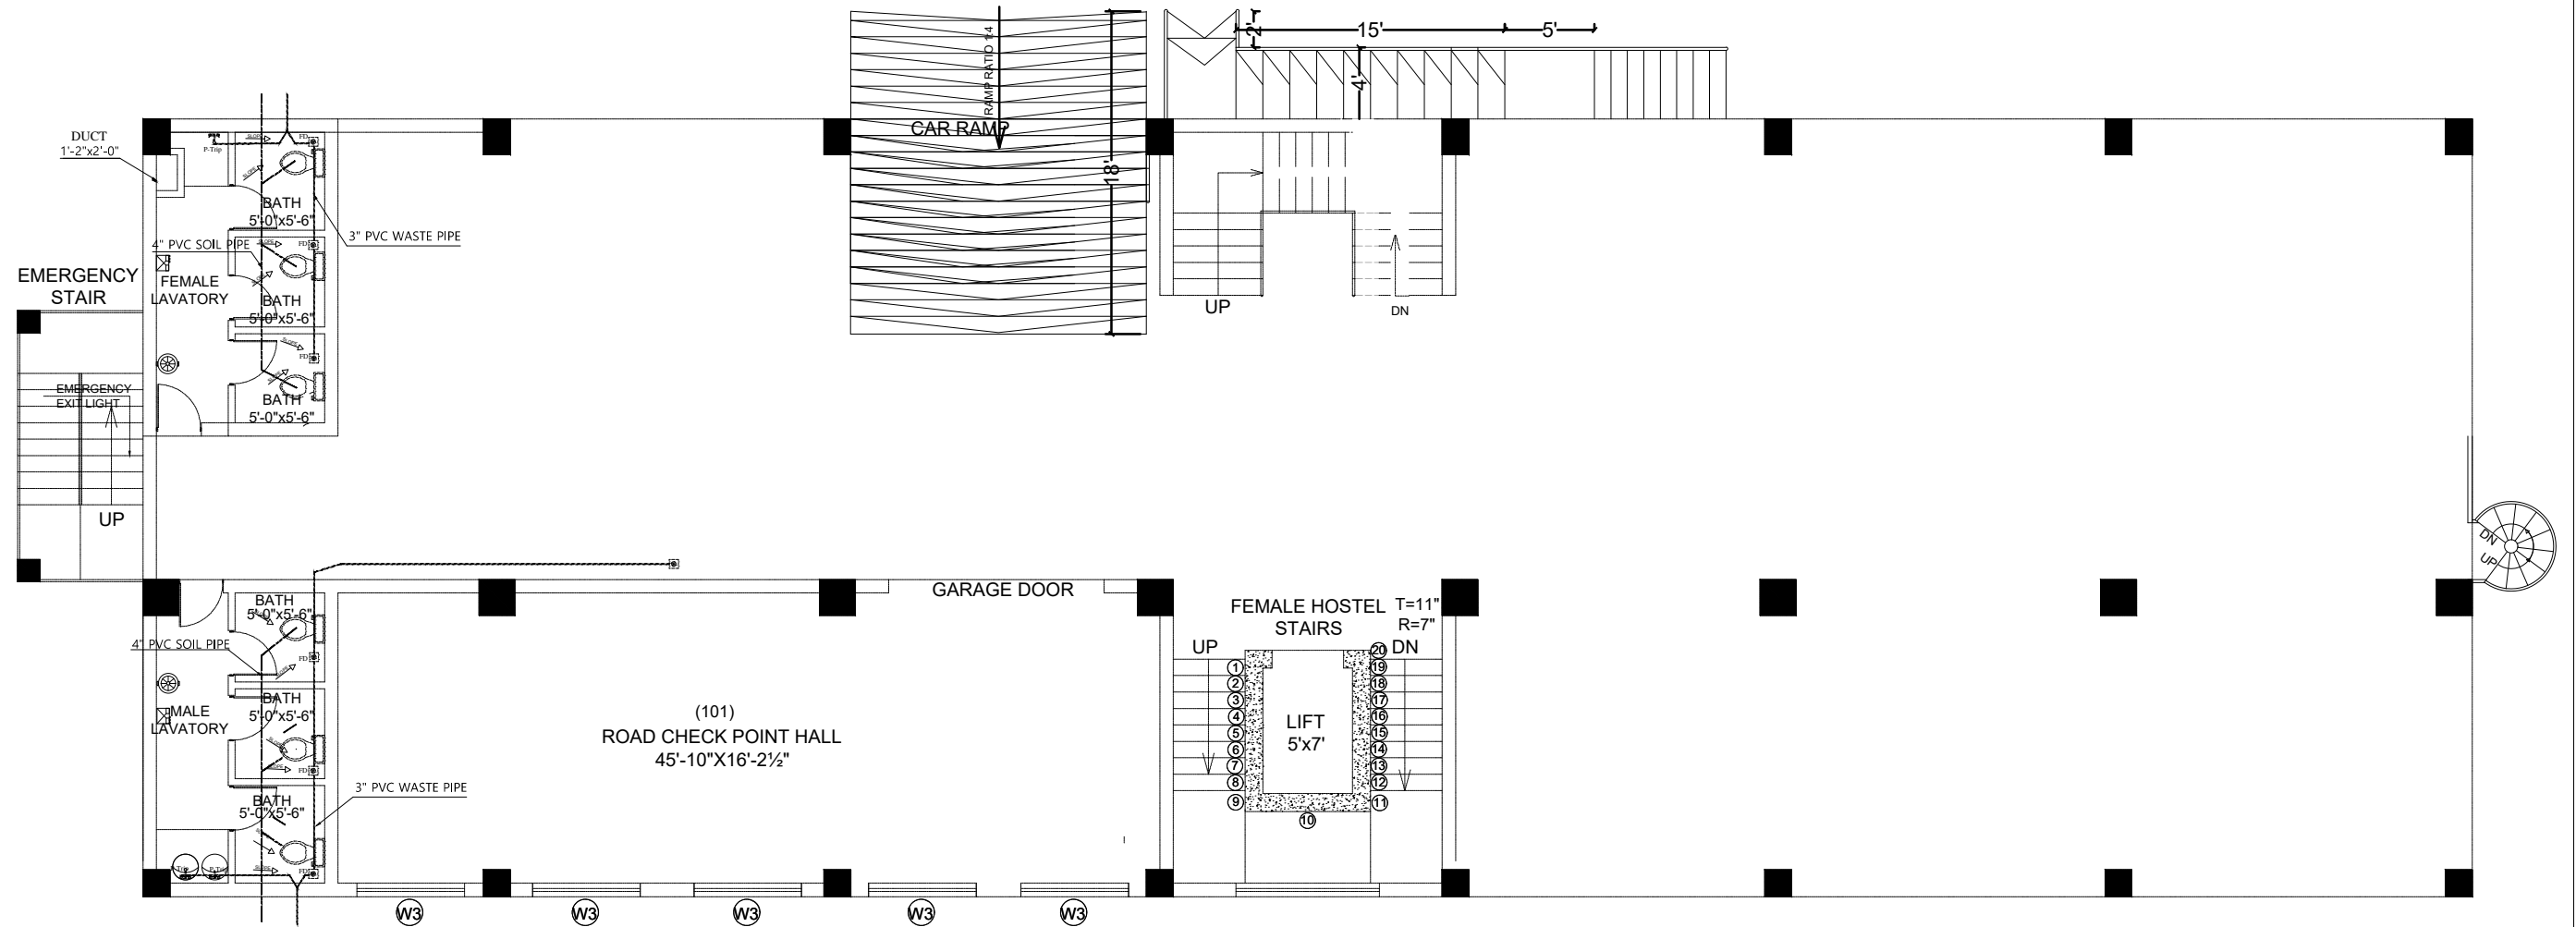

GROUND FLOOR PLAN

Project

ANTI-NARCOTIC FORCE ACADEMY
EXTENSION AND WOMEN'S HOSTEL


Client

UNITED NATIONS DEVELOPMENT PROGRAMME

Funding Agency

INTERNATIONAL NARCOTICS AND LAW
ENFORCEMENT AFFAIRS (INL)

Consultant

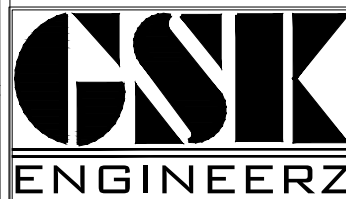


GSK ENGINEERZ

PLANNING - TESTING - DESIGNING & DEVELOPMENT
FLAT NO.205 & 206 2nd Floor, Afzal Tower Phase 3,
Main Intersection, Peshawar
Ph: +92-333-912-6118, +92-334-843-5340
E-mail: gsk.engineerz@gmail.com

SCALE : N.T.S	ARCHITECT : ASAD HASSAN
SHEET NO: PL - II	PREPARED BY : GHANI REHMAN
DATE : AUG - 2021	DRAWING TITLE: GROUND FLOOR DRAINAGE
PLUMBING DRAWING	



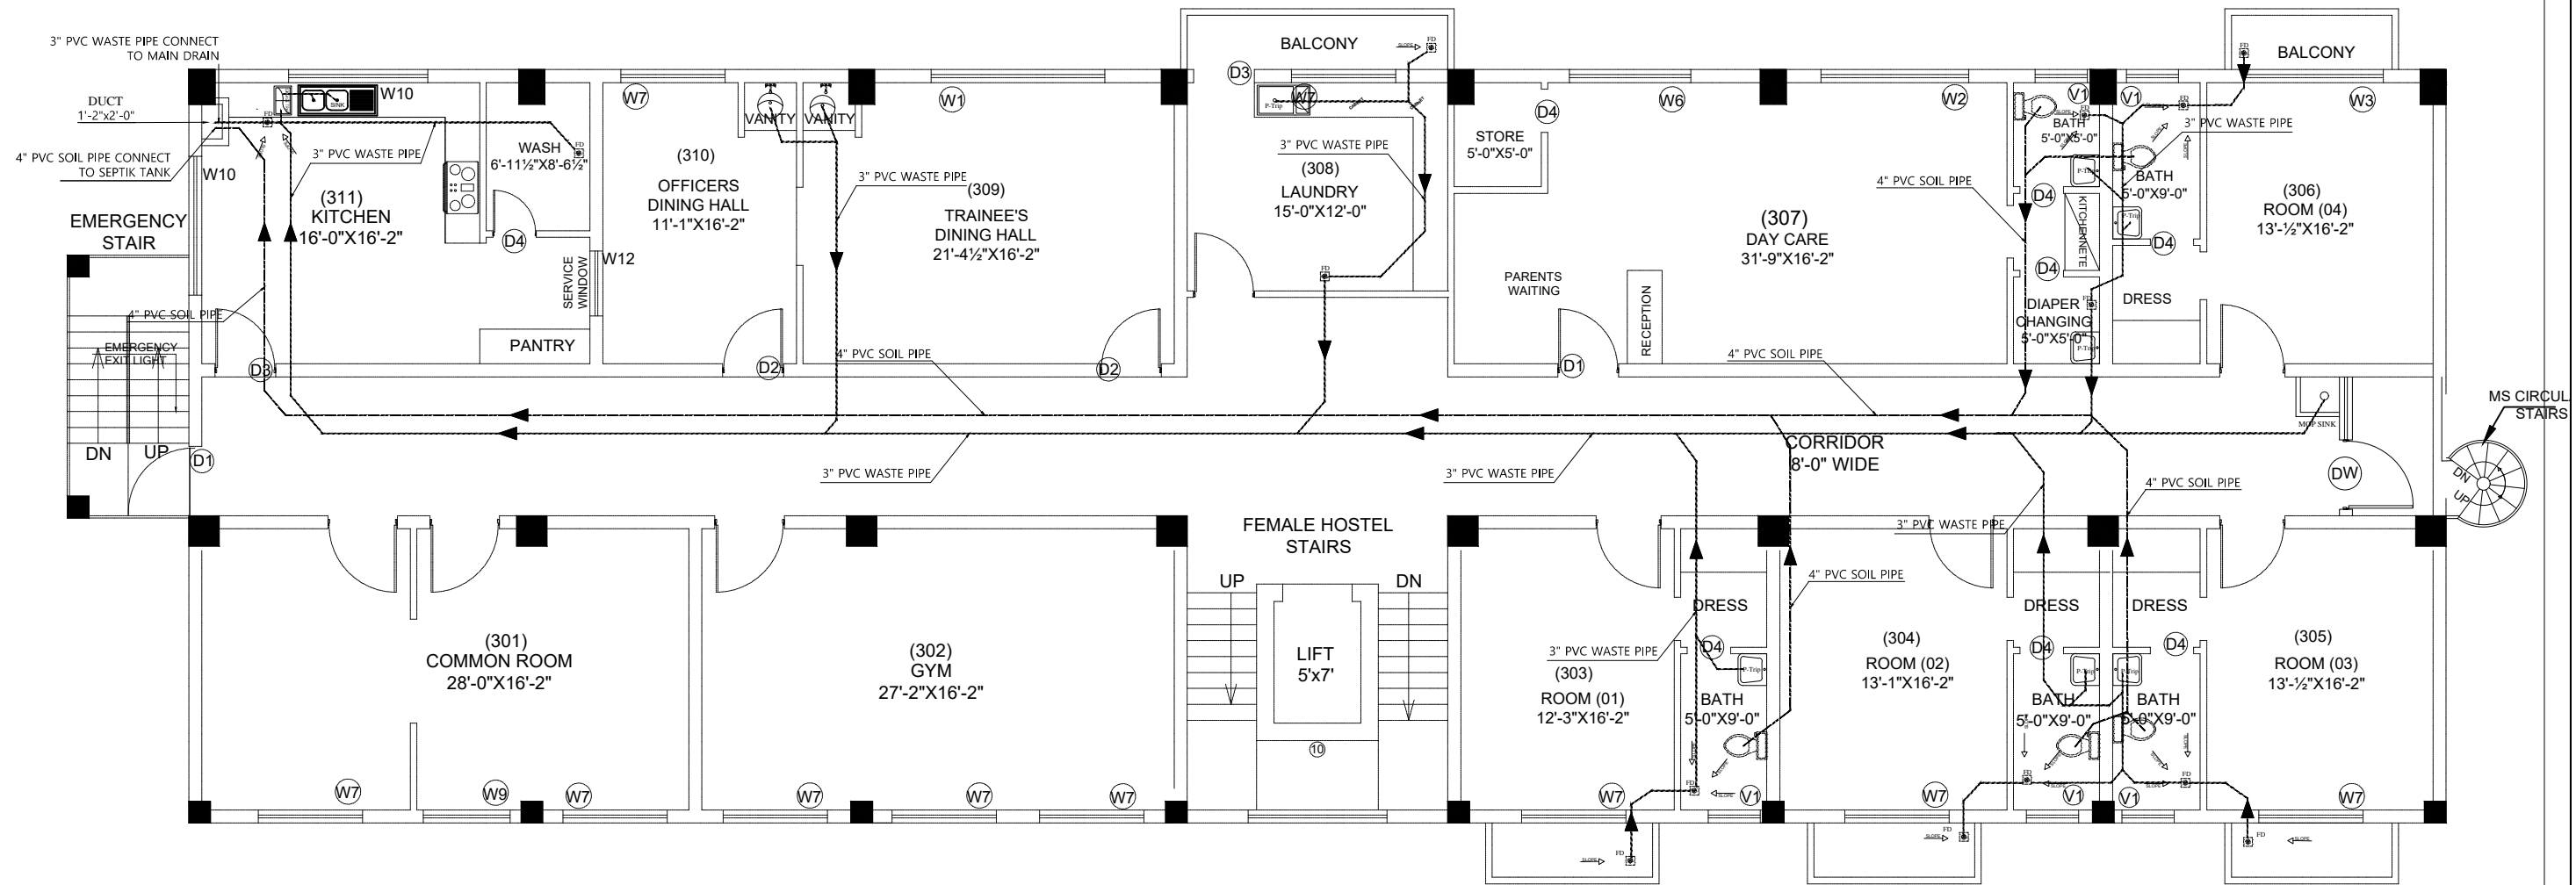

2ND FLOOR PLAN

Project

ANTI-NARCOTIC FORCE ACADEMY
EXTENSION AND WOMEN'S HOSTEL


Client

UNITED NATIONS DEVELOPMENT PROGRAMME

Funding Agency

INTERNATIONAL NARCOTICS AND LAW
ENFORCEMENT AFFAIRS (INL)

Consultant

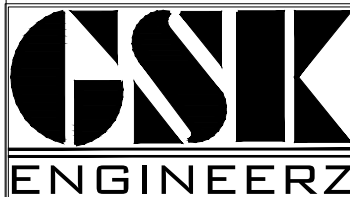


GSK ENGINEERZ

PLANNING - TESTING - DESIGNING & DEVELOPMENT
FLAT NO.205 & 206 2nd Floor, Afzal Tower Phase 3,
Main Intersection, Peshawar
Ph: +92-333-912-6118, +92-334-843-5340
E-mail: gsk.engineerz@gmail.com

SCALE :	N.T.S	ARCHITECT :	ASAD HASSAN
SHEET NO:	PL - I3	PREPARED BY :	GHANI REHMAN
DATE :	AUG -2021	DRAWING TITLE:	2ND FLOOR DRAINAGE
PLUMBING DRAWING			



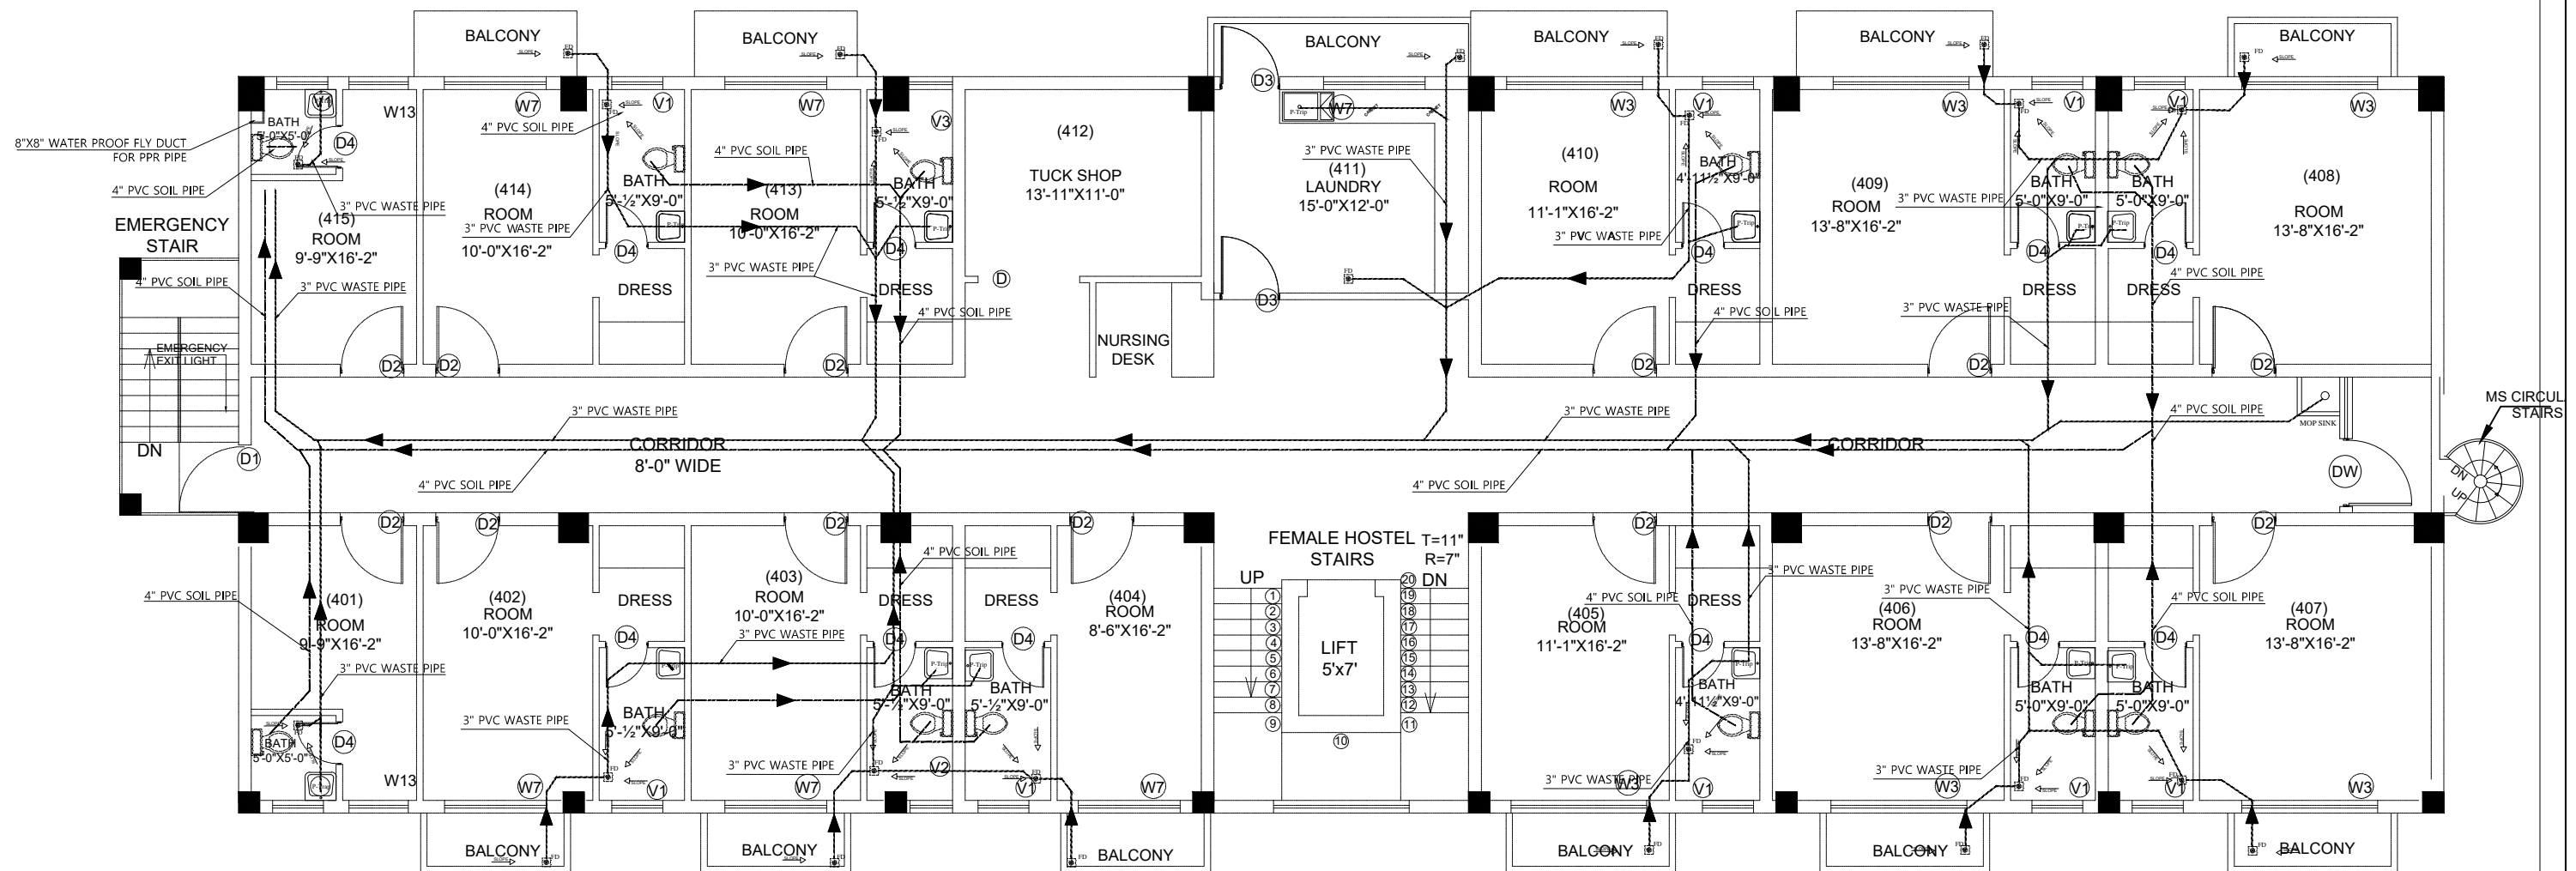

3RD FLOOR PLAN

Project

ANTI-NARCOTIC FORCE ACADEMY
EXTENSION AND WOMEN'S HOSTEL


Client

UNITED NATIONS DEVELOPMENT PROGRAMME

Funding Agency

INTERNATIONAL NARCOTICS AND LAW
ENFORCEMENT AFFAIRS (INL)


Consultant

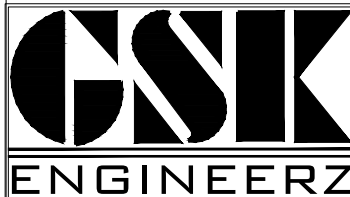


GSK ENGINEERZ


PLANNING - TESTING - DESIGNING & DEVELOPMENT
FLAT NO.205 & 206 2nd Floor, Afzal Tower Phase 3,
Main Intersection, Peshawar
Ph: +92-333-912-6118, +92-334-843-5340
E-mail: gsk.engineerz@gmail.com

SCALE :	N.T.S	ARCHITECT :	ASAD HASSAN
SHEET NO:	PL - 14	PREPARED BY :	GHANI REHMAN
DATE :	AUG - 2021	DRAWING TITLE:	3RD FLOOR DRAINAGE
PLUMBING DRAWING			

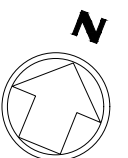

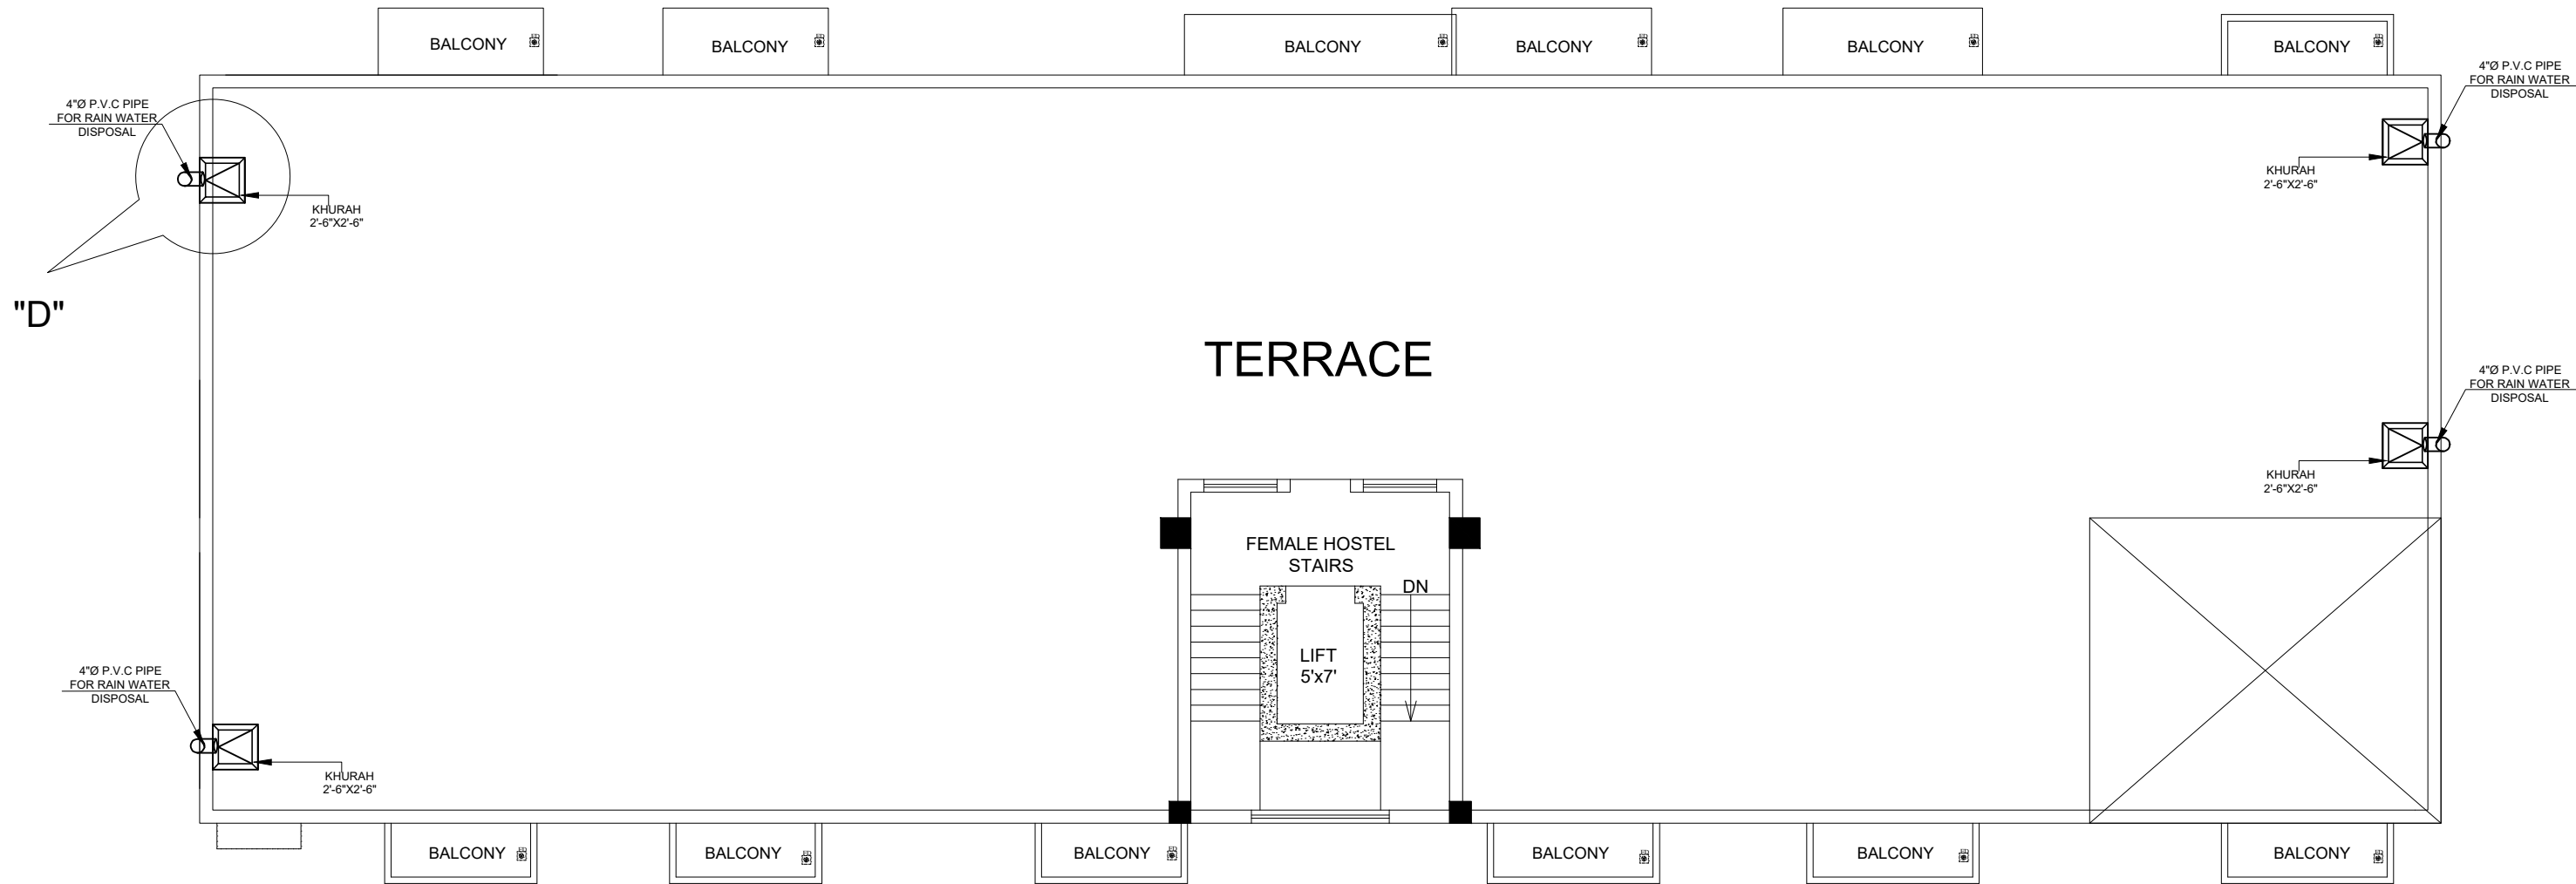

TOP ROOF PLAN

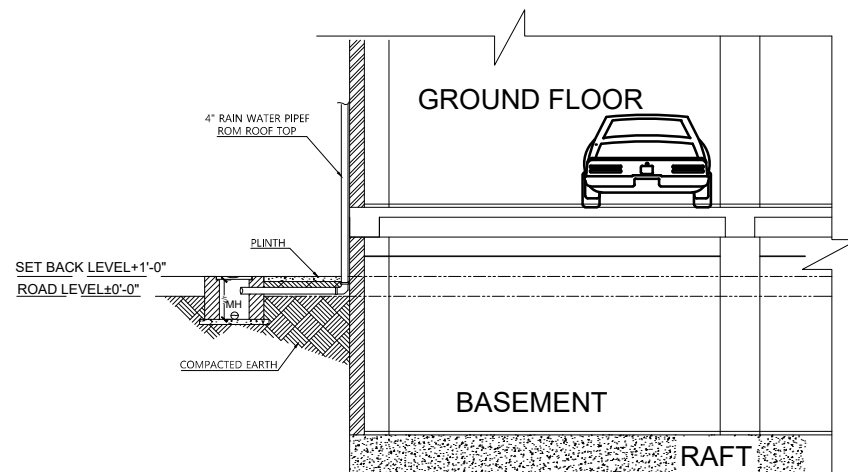

DETAIL-D

Project

ANTI-NARCOTIC FORCE ACADEMY
EXTENSION AND WOMEN'S HOSTEL


Client

UNITED NATIONS DEVELOPMENT PROGRAMME

Funding Agency

INTERNATIONAL NARCOTICS AND LAW
ENFORCEMENT AFFAIRS (INL)

Consultant

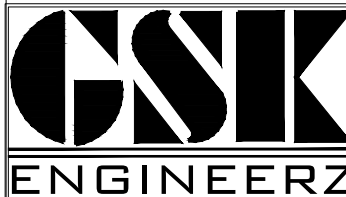


GSK ENGINEERZ

PLANNING - TESTING - DESIGNING & DEVELOPMENT
FLAT NO.205 & 206 2nd Floor, Afzal Tower Phase 3,
Main Intersection, Peshawar
Ph: +92-333-912-6118, +92-334-843-5340
E.mail: gsk.engineerz@gmail.com

SCALE :	ARCHITECT :	ASAD HASSAN
N.T.S	PREPARED BY :	GHANI REHMAN
SHEET NO:	DRAWING TITLE:	ROOF TOP DRAINAGE
PL - I5		
DATE :		
AUG - 2021		
PLUMBING DRAWING		



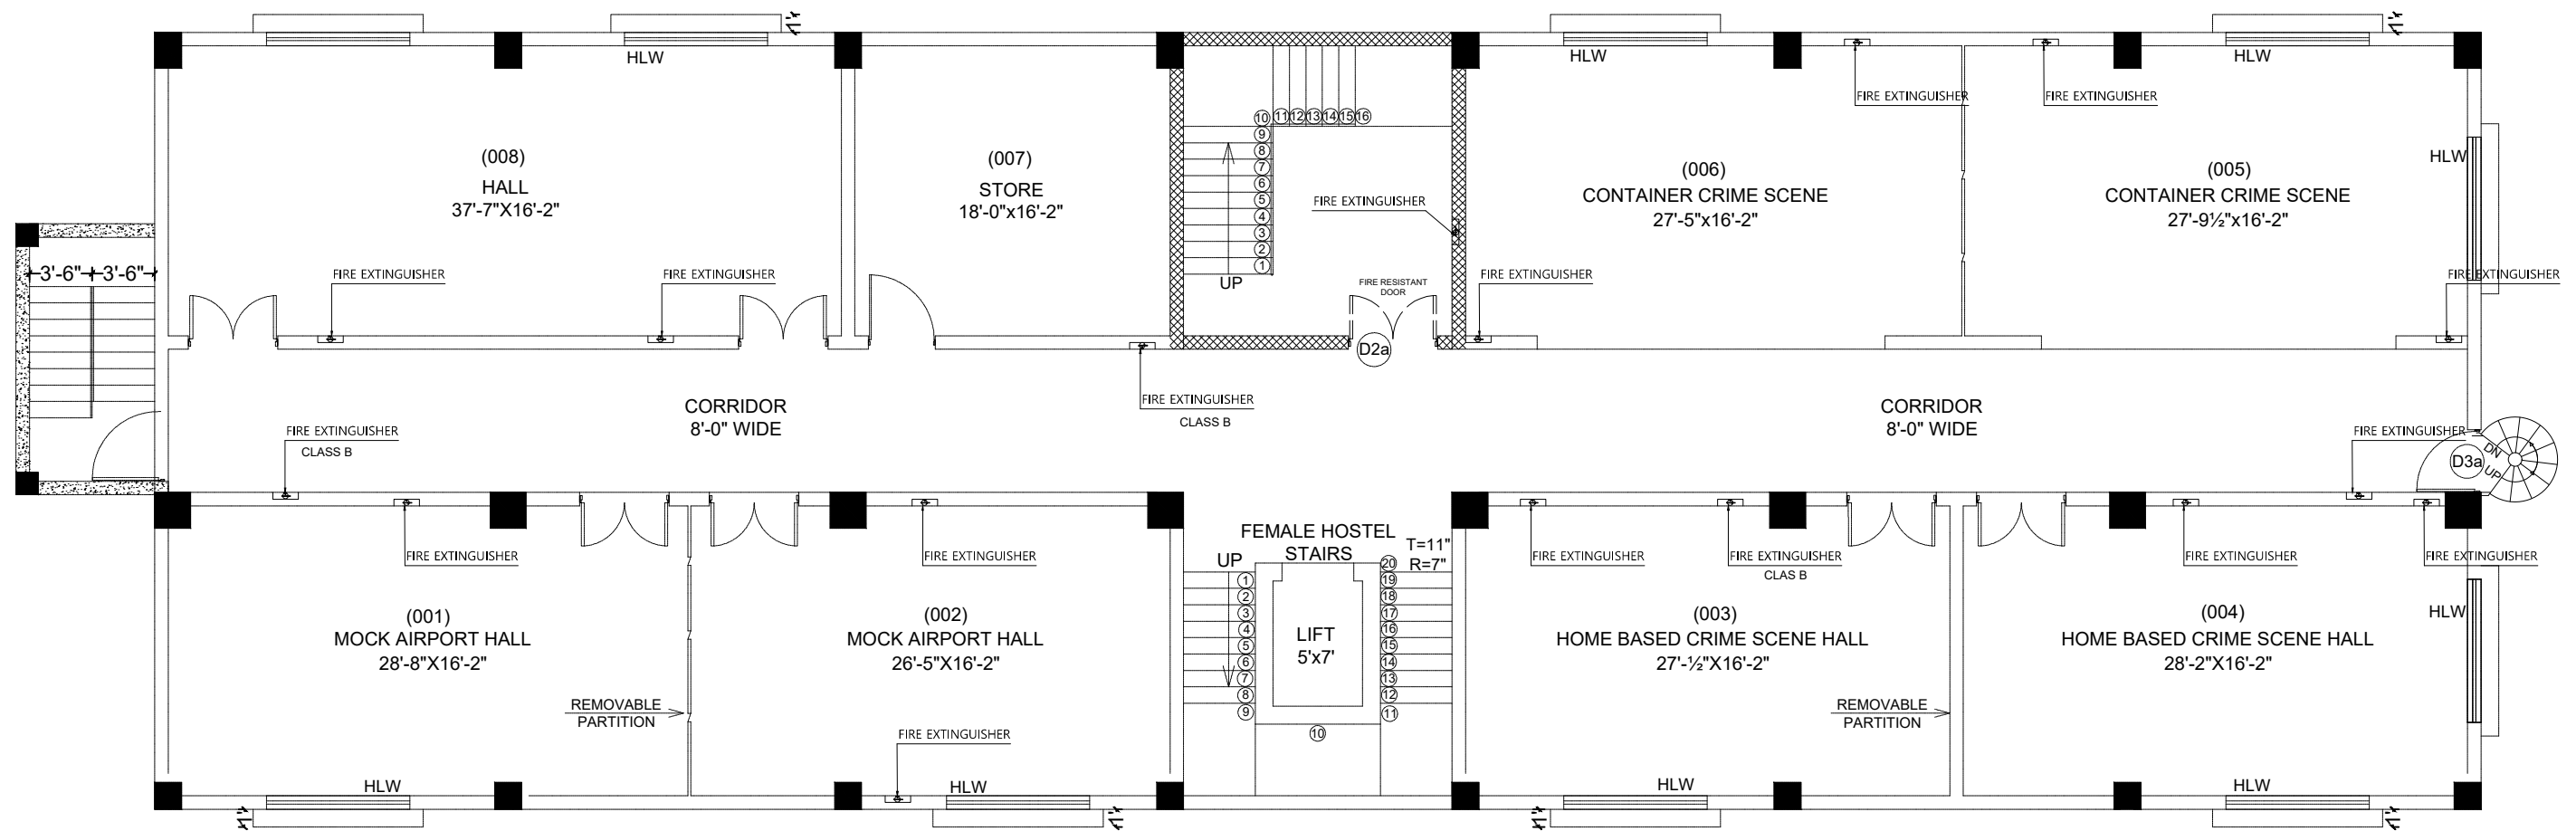

NOTE: All Fire extinguishers will be Class B,
(Portable) CO2, 7 Kg capacity.

BASEMENT PLAN

Project

ANTI-NARCOTIC FORCE ACADEMY
EXTENSION AND WOMEN'S HOSTEL


Client

UNITED NATIONS DEVELOPMENT PROGRAMME

Funding Agency

INTERNATIONAL NARCOTICS AND LAW
ENFORCEMENT AFFAIRS (INL)


Consultant

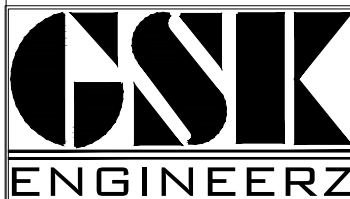


GSK ENGINEERZ

PLANNING - TESTING - DESIGNING & DEVELOPMENT
FLAT NO.205 & 206 2nd Floor, Afzal Tower Phase 3,
Main Intersection, Peshawar
Ph: +92-333-912-6118, +92-334-843-5340
E.mail: gsk.engineerz@gmail.com

SCALE :	N.T.S	ARCHITECT :	ASAD HASSAN
SHEET NO:	FF - 01	PREPARED BY :	GHANI REHMAN
DATE :	AUG - 2021	DRAWING TITLE:	BASEMENT FLOOR FIRE FIGHTING
FIRE FIGHTING DRAWING			

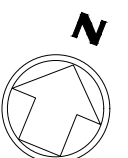

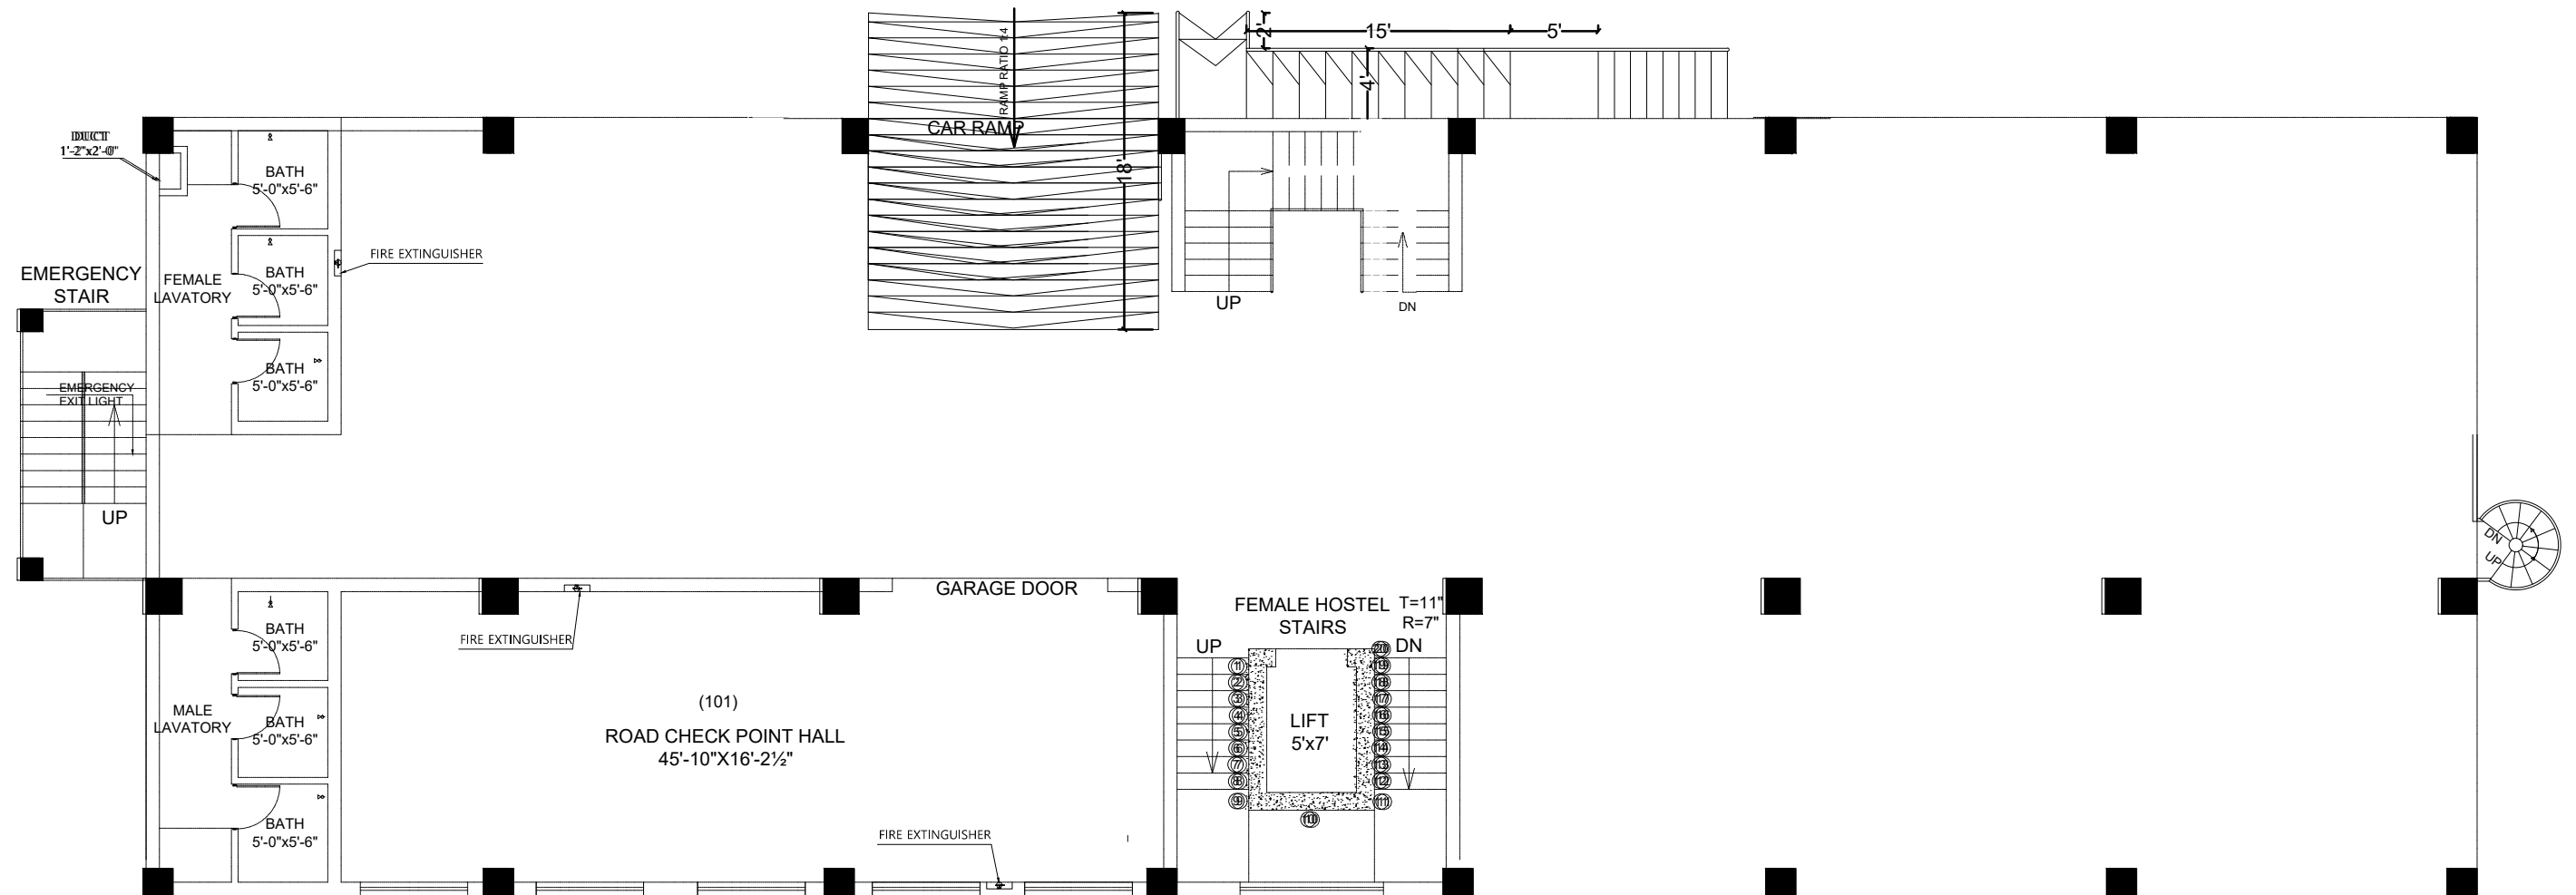

GROUND FLOOR PLAN

NOTE: All Fire extinguishers will be Class B,
(Portable) CO2, 7 Kg capacity.

Project

ANTI-NARCOTIC FORCE ACADEMY
EXTENSION AND WOMEN'S HOSTEL


Client

UNITED NATIONS DEVELOPMENT PROGRAMME

Funding Agency

INTERNATIONAL NARCOTICS AND LAW
ENFORCEMENT AFFAIRS (INL)

Consultant

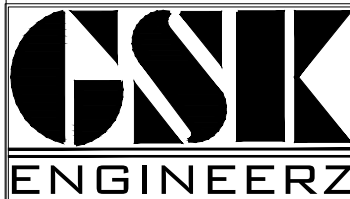


GSK ENGINEERZ

PLANNING - TESTING - DESIGNING & DEVELOPMENT
FLAT NO.205 & 206 2nd Floor, Afzal Tower Phase 3,
Main Intersection, Peshawar
Ph: +92-333-912-6118, +92-334-843-5340
E.mail: gsk.engineerz@gmail.com

SCALE :	ARCHITECT :	ASAD HASSAN
N.T.S	PREPARED BY :	GHANI REHMAN
SHEET NO:	DRAWING TITLE:	GROUND FLOOR FIRE FIGHTING
FF - 02		
DATE :		
AUG - 2021		
FIRE FIGHTING DRAWING		



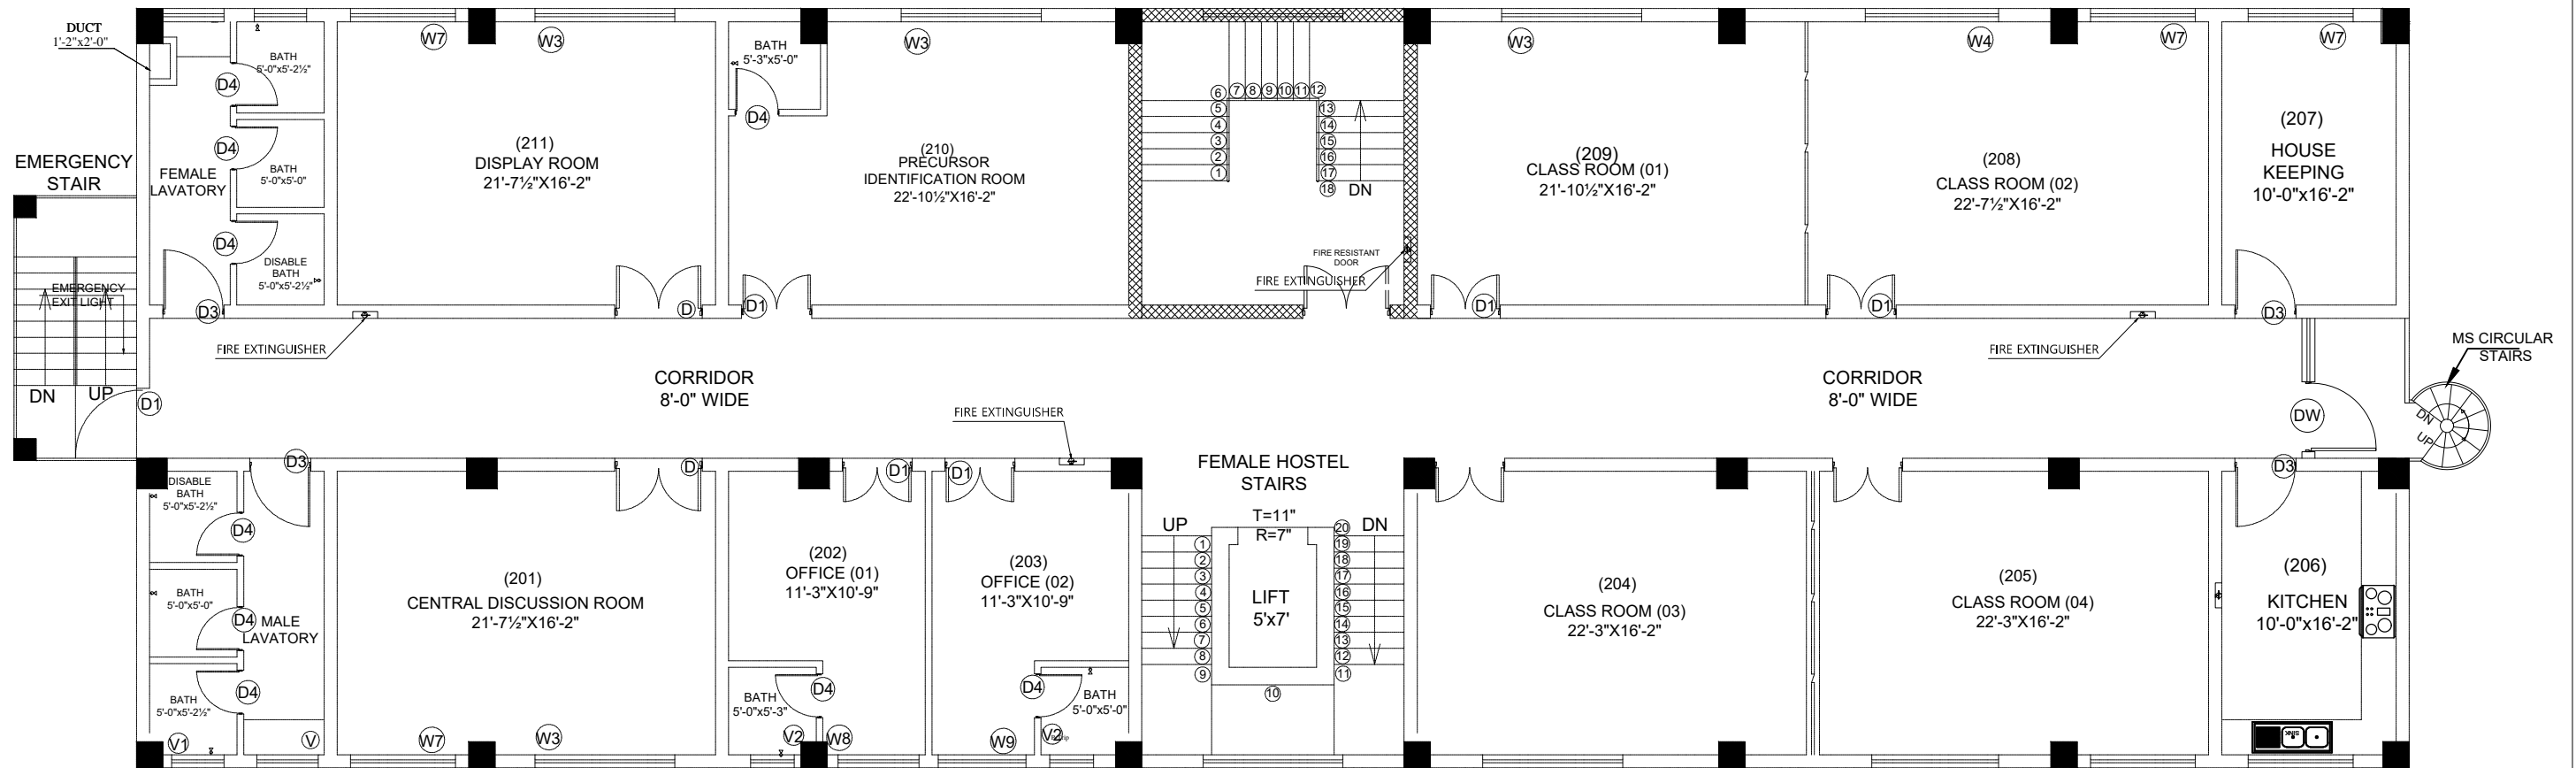

FIRST FLOOR PLAN

NOTE: All Fire extinguishers will be Class B,
(Portable) CO2, 7 Kg capacity.

Project

ANTI-NARCOTIC FORCE ACADEMY
EXTENSION AND WOMEN'S HOSTEL


Client

UNITED NATIONS DEVELOPMENT PROGRAMME

Funding Agency

INTERNATIONAL NARCOTICS AND LAW
ENFORCEMENT AFFAIRS (INL)


Consultant

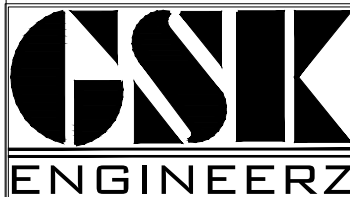

GSK ENGINEERZ
PLANNING - TESTING - DESIGNING & DEVELOPMENT
FLAT NO.205 & 206 2nd Floor, Afzal Tower Phase 3,
Main Intersection, Peshawar
Ph: +92-333-912-6118, +92-334-843-5340
E-mail: gsk.engineerz@gmail.com

SCALE :	N.T.S	ARCHITECT :	ASAD HASSAN
SHEET NO:	FF - 03	PREPARED BY :	GHANI REHMAN
DATE :	AUG - 2021	DRAWING TITLE:	FIRST FLOOR FIRE FIGHTING
FIRE FIGHTING DRAWING			



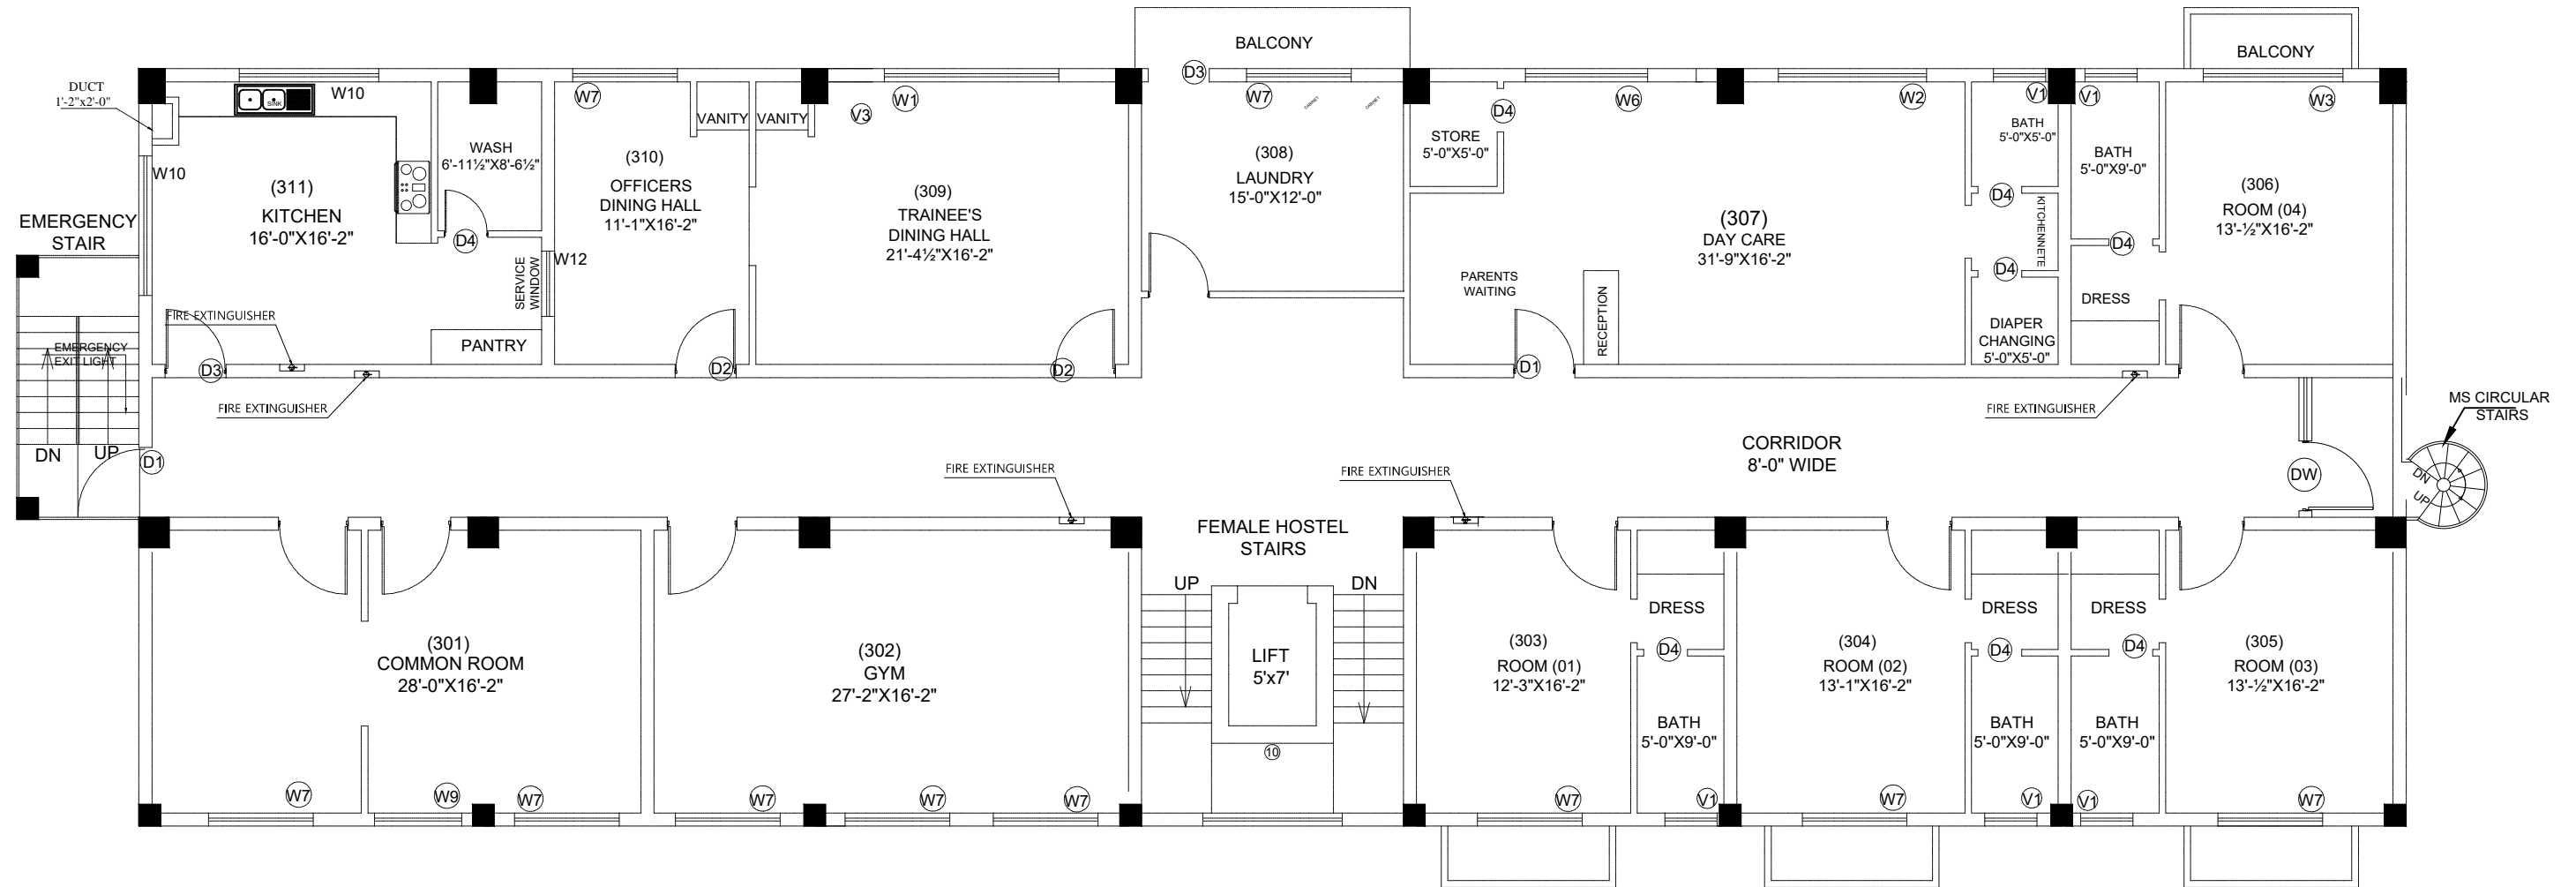

2ND FLOOR PLAN

NOTE: All Fire extinguishers will be Class B, (Portable) CO2, 7 Kg capacity.

Project

ANTI-NARCOTIC FORCE ACADEMY
EXTENSION AND WOMEN'S HOSTEL


Client

UNITED NATIONS DEVELOPMENT PROGRAMME

Funding Agency

INTERNATIONAL NARCOTICS AND LAW
ENFORCEMENT AFFAIRS (INL)

Consultant

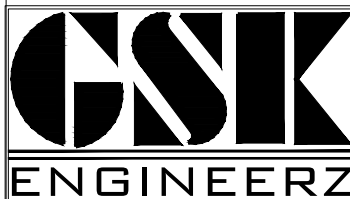


GSK ENGINEERZ

PLANNING - TESTING - DESIGNING & DEVELOPMENT
FLAT NO.205 & 206 2nd Floor, Afzal Tower Phase 3,
Main Intersection, Peshawar
Ph: +92-333-912-6118, +92-334-843-5340
E.mail: gsk.engineerz@gmail.com

SCALE :	N.T.S	ARCHITECT :	ASAD HASSAN
SHEET NO:	FF - 04	PREPARED BY :	GHANI REHMAN
DATE :	AUG - 2021	DRAWING TITLE:	2ND FLOOR FIRE FIGHTING
FIRE FIGHTING DRAWING			



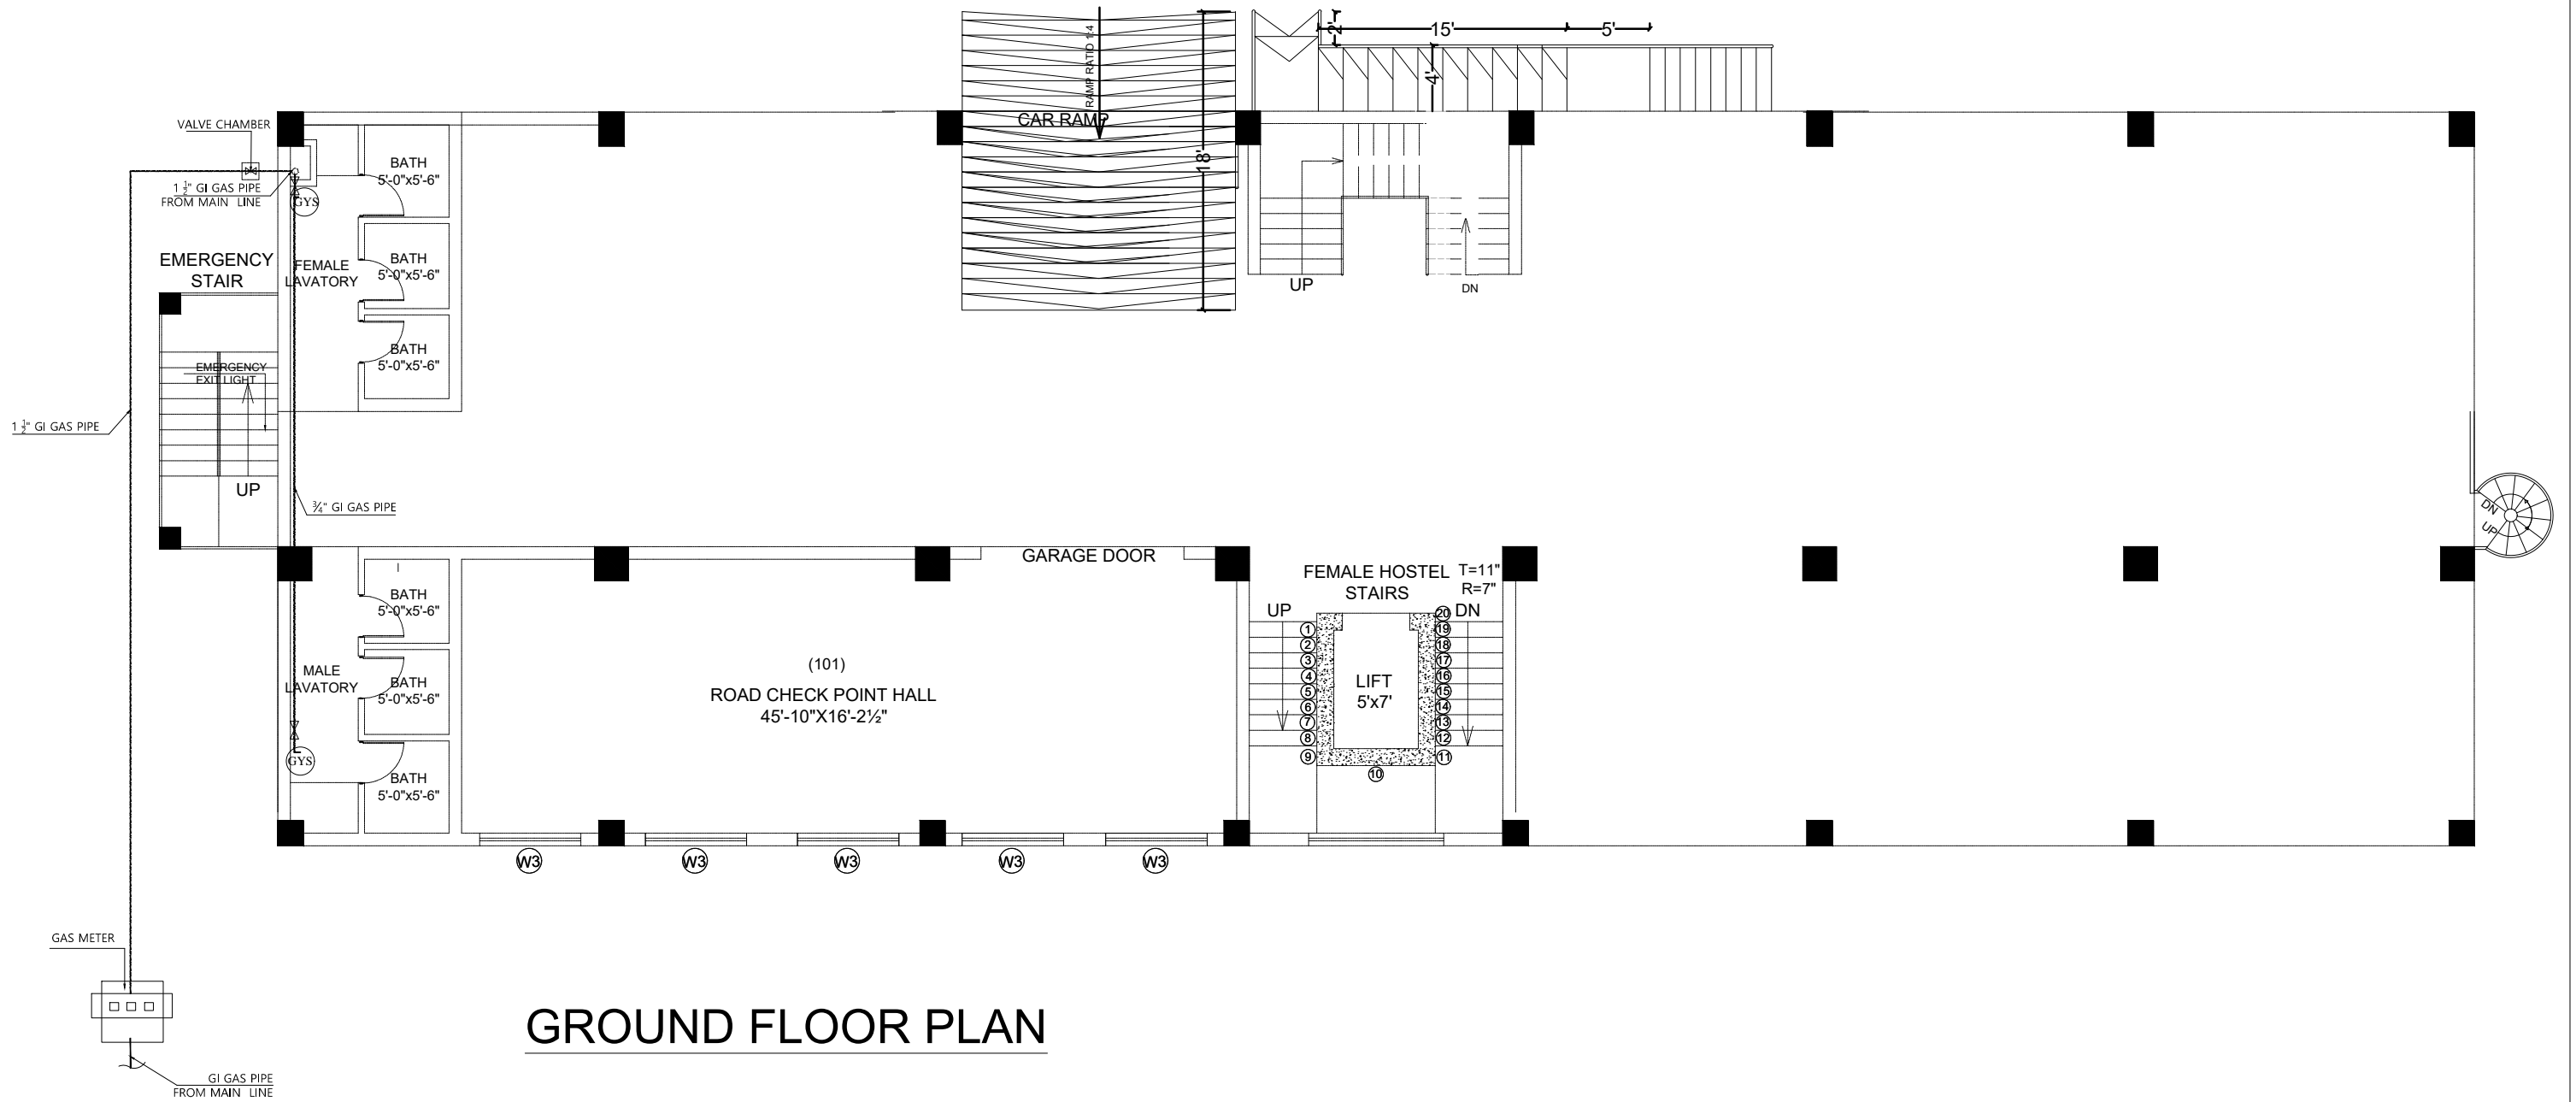

Project

ANTI-NARCOTIC FORCE ACADEMY
EXTENSION AND WOMEN'S HOSTEL


Client

UNITED NATIONS DEVELOPMENT PROGRAMME

Funding Agency

INTERNATIONAL NARCOTICS AND LAW
ENFORCEMENT AFFAIRS (INL)

Consultant

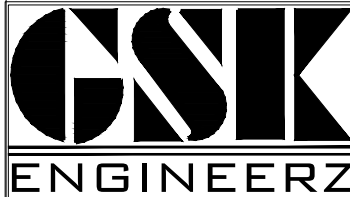


GSK ENGINEERZ

PLANNING - TESTING - DESIGNING & DEVELOPMENT
FLAT NO.205 & 206 2nd Floor, Afzal Tower Phase 3,
Main Intersection, Peshawar
Ph: +92-333-912-6118, +92-334-843-5340
E.mail: gsk.engineerz@gmail.com

SCALE :	ARCHITECT :	ASAD HASSAN
N.T.S	PREPARED BY :	GHANI REHMAN
SHEET NO:	DRAWING TITLE:	GROUND FLOOR GAS PLAN
GS-01		
DATE :		
AUG-2021		
PLUMBING DRAWING		



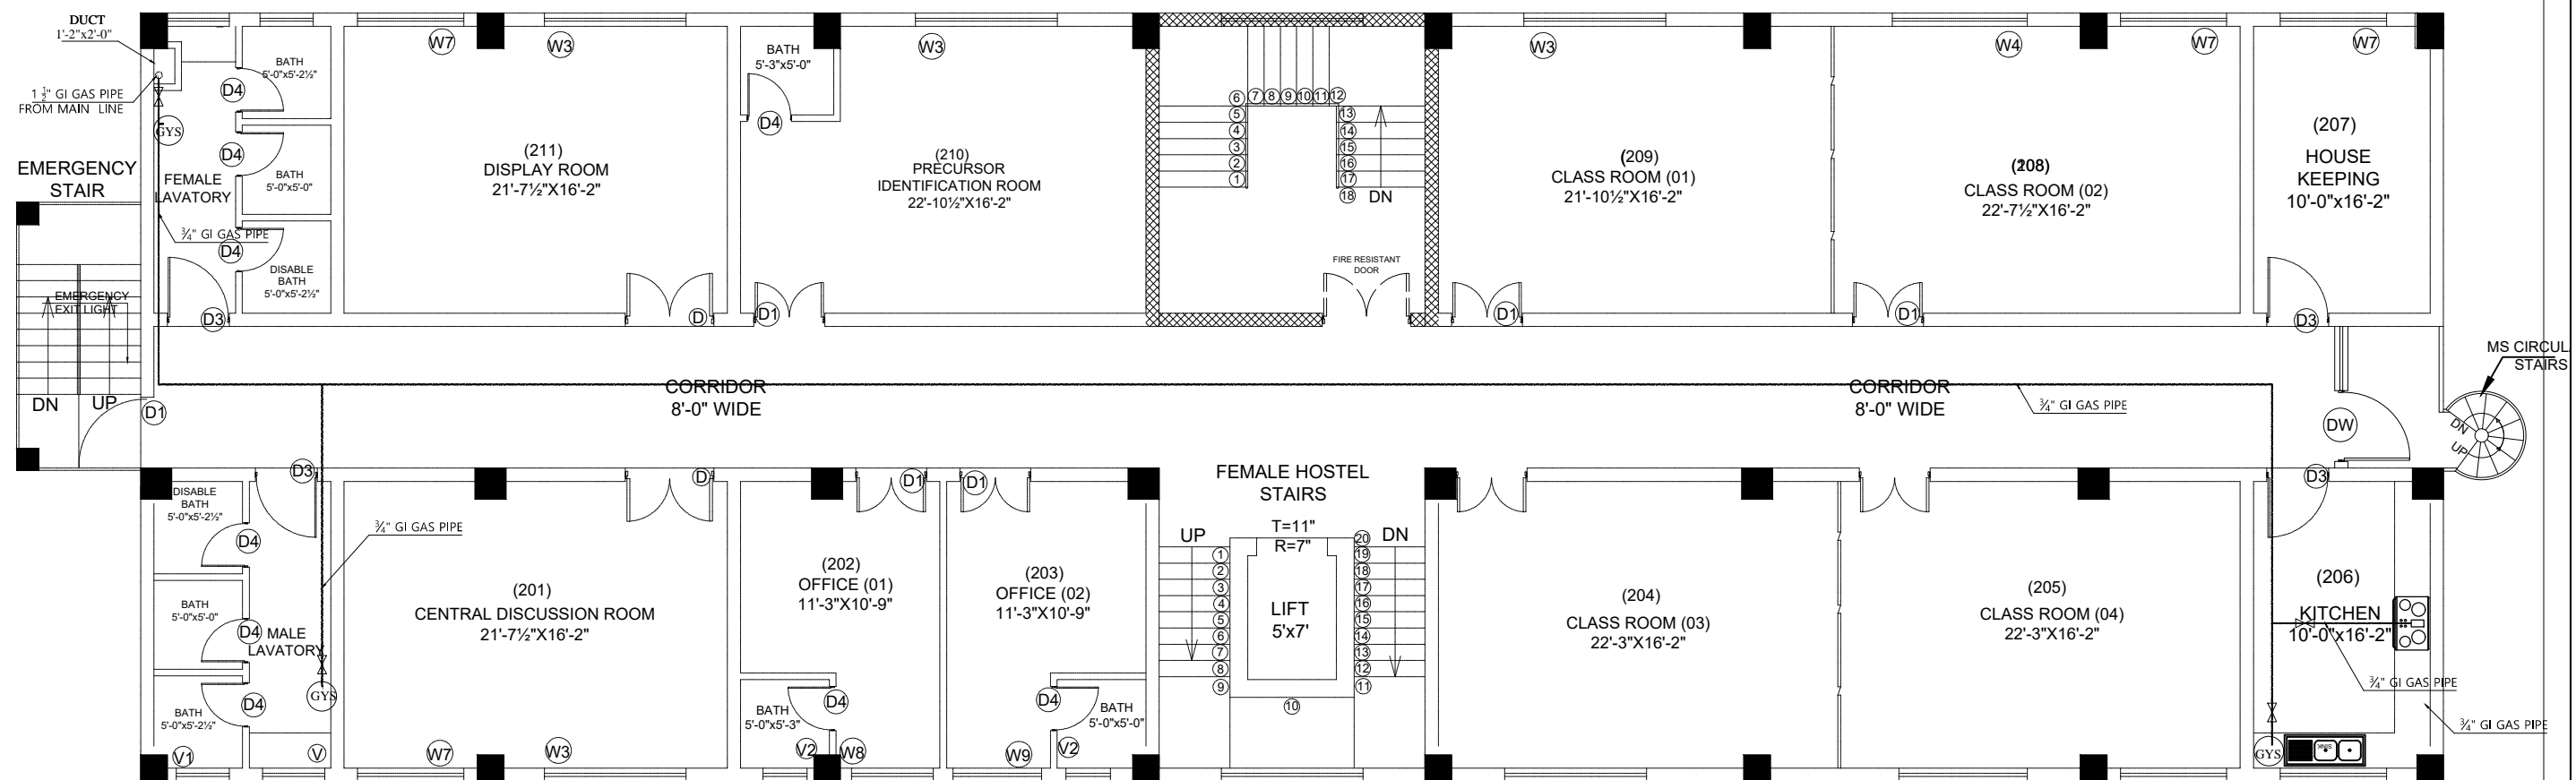

FIRST FLOOR PLAN

Project

ANTI-NARCOTIC FORCE ACADEMY
EXTENSION AND WOMEN'S HOSTEL


Client

UNITED NATIONS DEVELOPMENT PROGRAMME

Funding Agency

INTERNATIONAL NARCOTICS AND LAW
ENFORCEMENT AFFAIRS (INL)

Consultant

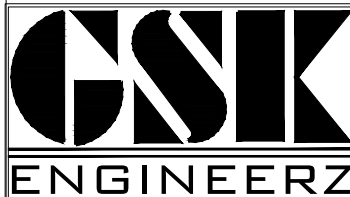


GSK ENGINEERZ

PLANNING - TESTING - DESIGNING & DEVELOPMENT
FLAT NO.205 & 206 2nd Floor, Atzal Tower Phase 3,
Main Intersection, Peshawar
Ph: +92-333-912-6118, +92-334-843-5340
E-mail: gsk.engineerz@gmail.com

SCALE :	N.T.S	ARCHITECT :	ASAD HASSAN
SHEET NO:	GS - 02	PREPARED BY :	GHANI REHMAN
DATE :	AUG - 2021	DRAWING TITLE:	FIRST FLOOR GAS PLAN
NATURAL GAS DRAWING			



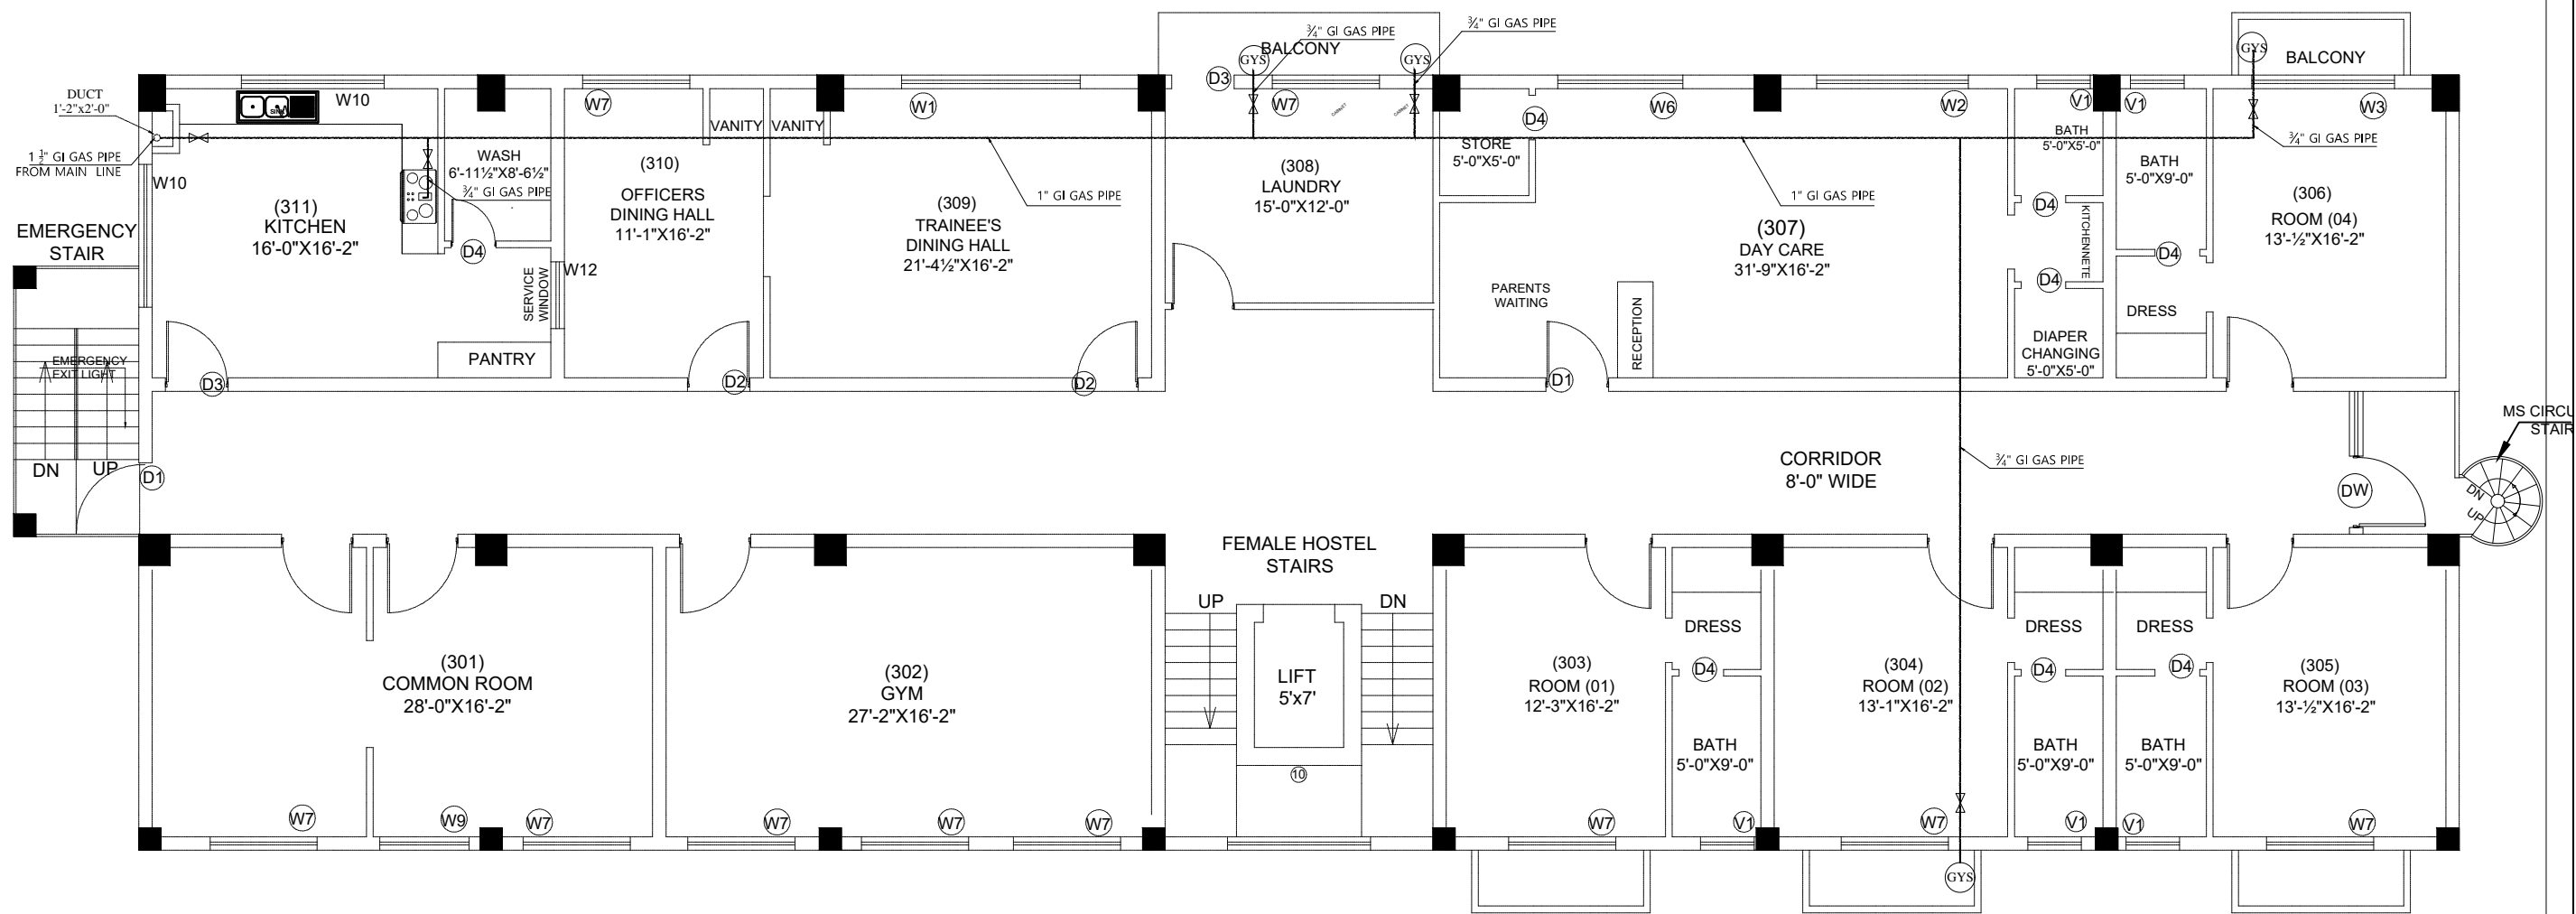

2ND FLOOR PLAN

Project

ANTI-NARCOTIC FORCE ACADEMY
EXTENSION AND WOMEN'S HOSTEL


Client

UNITED NATIONS DEVELOPMENT PROGRAMME

Funding Agency

INTERNATIONAL NARCOTICS AND LAW
ENFORCEMENT AFFAIRS (INL)


Consultant

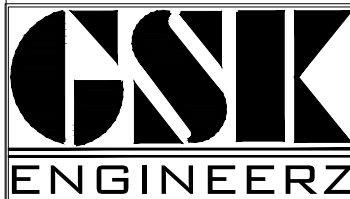


GSK ENGINEERZ

PLANNING - TESTING - DESIGNING & DEVELOPMENT
FLAT NO.205 & 206 2nd Floor, Afzal Tower Phase 3,
Main Intersection, Peshawar
Ph: +92-333-912-6118, +92-334-843-5340
E.mail: gsk.engineerz@gmail.com

SCALE :	N.T.S	ARCHITECT :	ASAD HASSAN
SHEET NO:	GS - 03	PREPARED BY :	GHANI REHMAN
DATE :	AUG - 2021	DRAWING TITLE:	2ND FLOOR GAS PLAN
NATURAL GAS DRAWING			

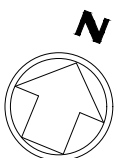

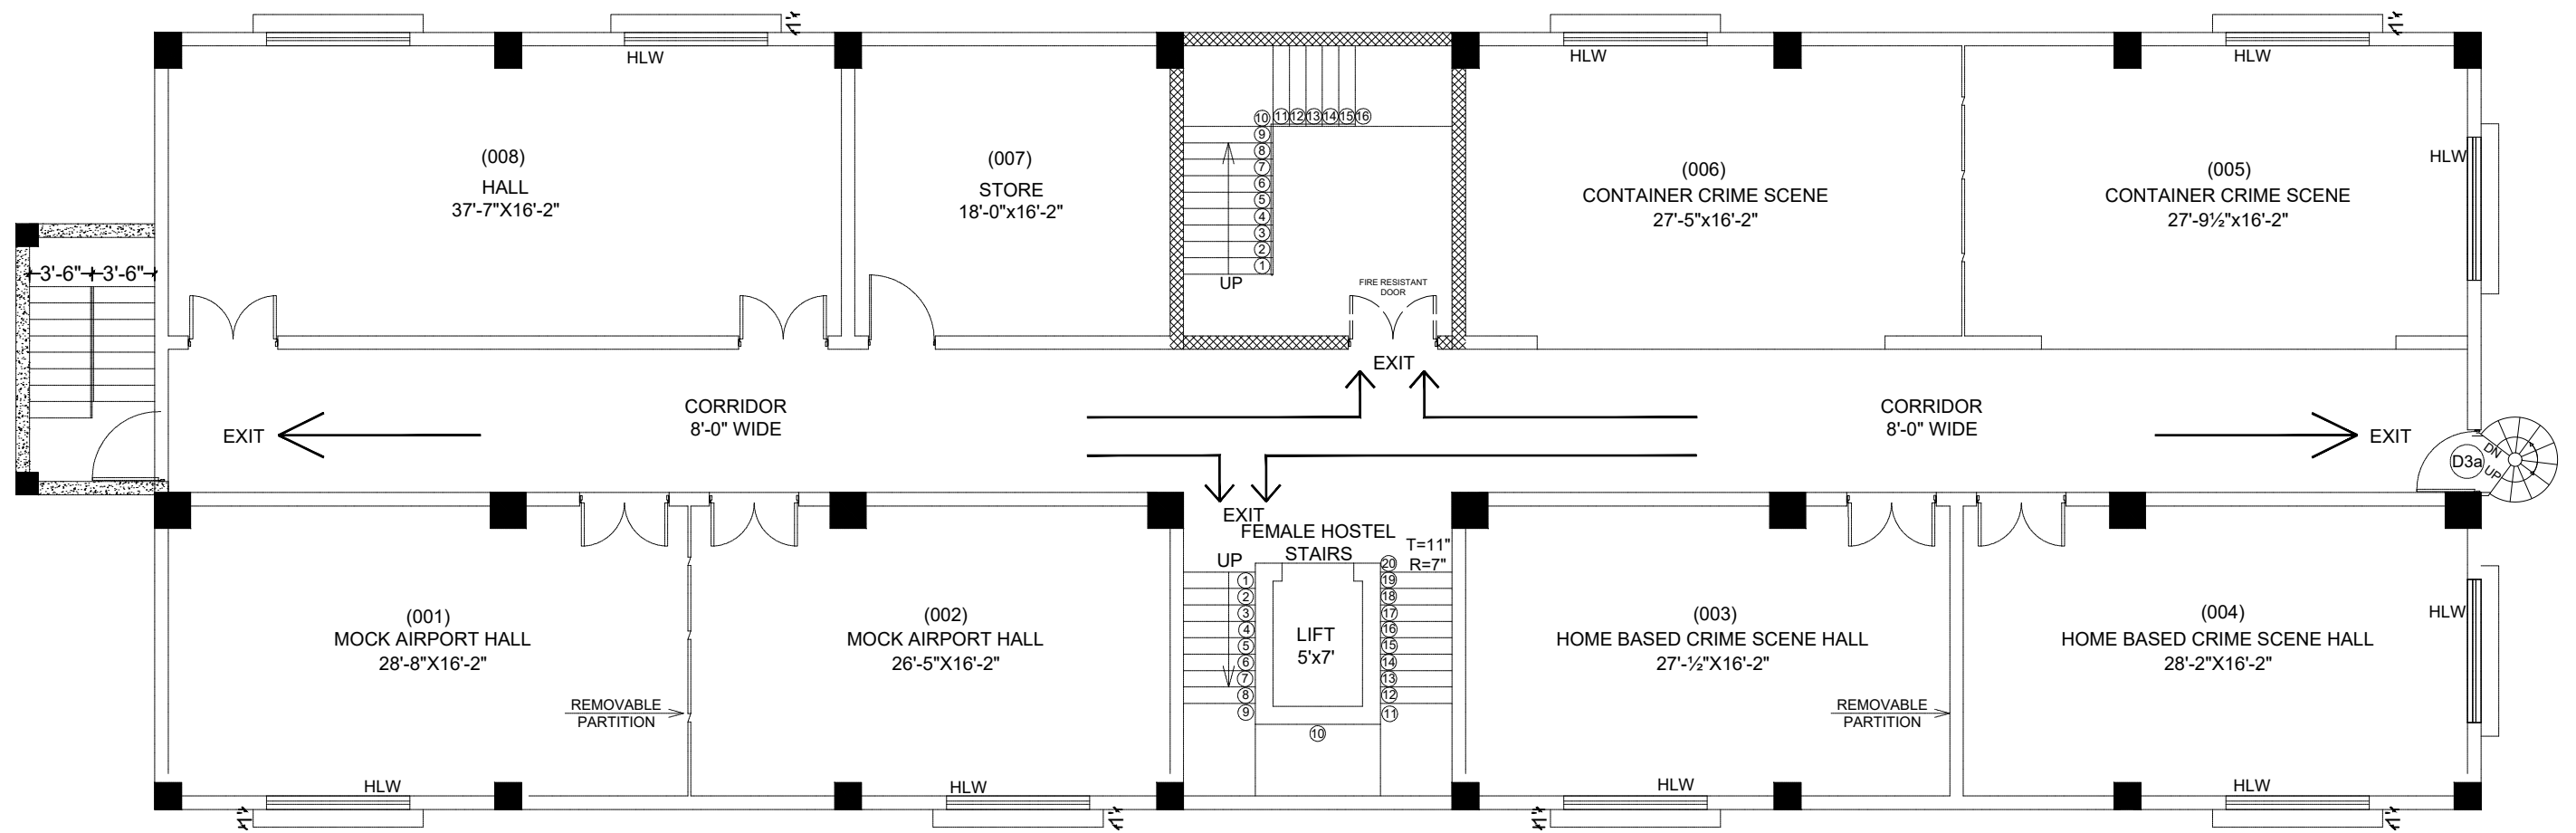

BASEMENT PLAN

Project

ANTI-NARCOTIC FORCE ACADEMY
EXTENSION AND WOMEN'S HOSTEL


Client

UNITED NATIONS DEVELOPMENT PROGRAMME

Funding Agency

INTERNATIONAL NARCOTICS AND LAW
ENFORCEMENT AFFAIRS (INL)


Consultant

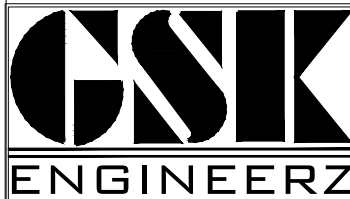

GSK ENGINEERZ
PLANNING - TESTING - DESIGNING & DEVELOPMENT
FLAT NO.205 & 206 2nd Floor, Afzal Tower Phase 3,
Main Intersection, Peshawar
Ph: +92-333-912-6118, +92-334-843-5340
E.mail: gsk.engineerz@gmail.com

SCALE :	ARCHITECT :	ASAD HASSAN
N.T.S	PREPARED BY :	GHANI REHMAN
SHEET NO:	DRAWING TITLE:	BASEMENT FLOOR LIFE SAFETY PLAN
LS - 01		
DATE :		
AUG - 2021		
FIRE FIGHTING DRAWING		



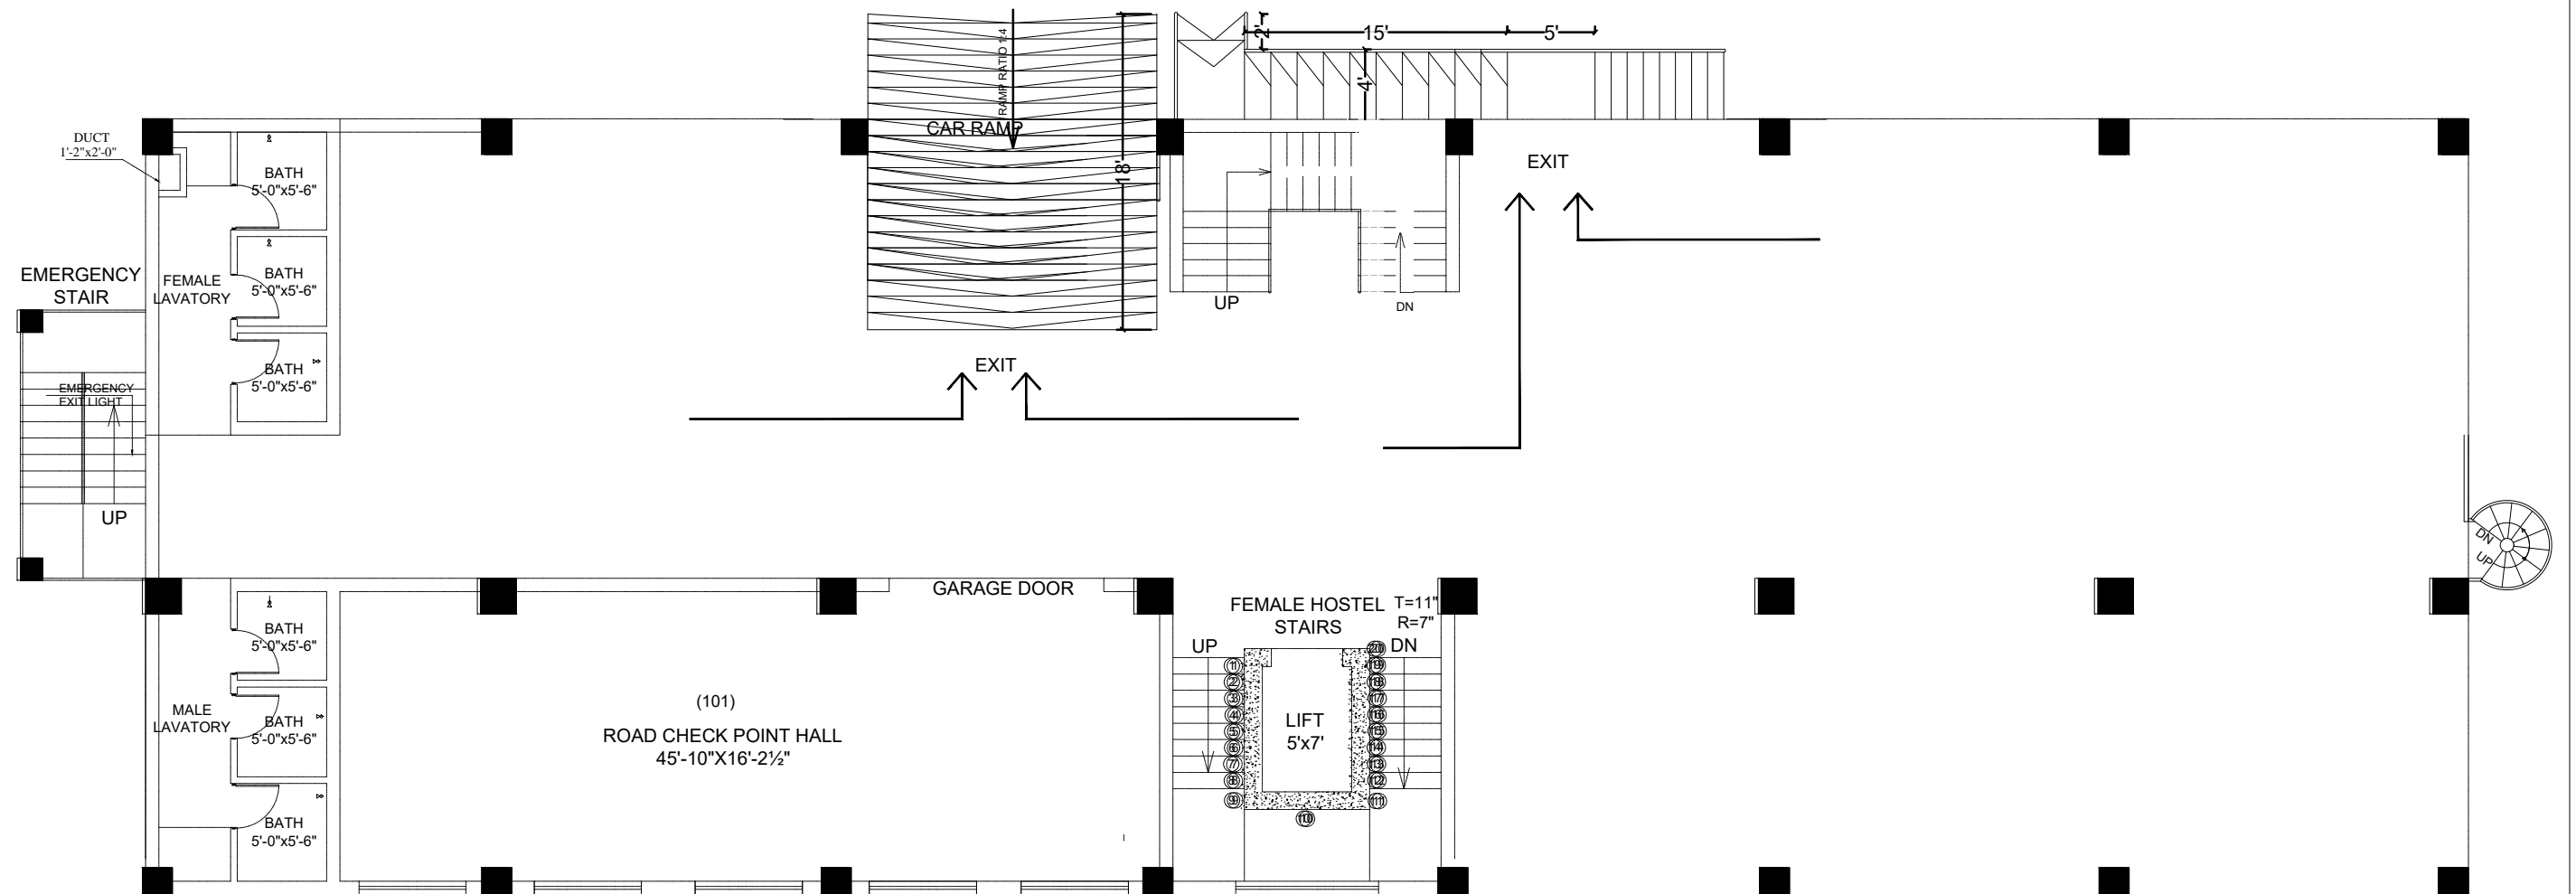

GROUND FLOOR PLAN

Project

ANTI-NARCOTIC FORCE ACADEMY
EXTENSION AND WOMEN'S HOSTEL

Client

UNITED NATIONS DEVELOPMENT PROGRAMME

Funding Agency

INTERNATIONAL NARCOTICS AND LAW
ENFORCEMENT AFFAIRS (INL)


Consultant

GSK ENGINEERZ

PLANNING - TESTING - DESIGNING & DEVELOPMENT
FLAT NO.205 & 206 2nd Floor, Afzal Tower Phase 3,
Main Intersection, Peshawar
Ph: +92-333-912-6118, +92-334-843-5340
E.mail: gsk.engineerz@gmail.com

SCALE :	ARCHITECT :	ASAD HASSAN
N.T.S	PREPARED BY :	GHANI REHMAN
SHEET NO:	DRAWING TITLE:	GROUND FLOOR LIFE SAFETY PLAN
LS - 02		
DATE :		
AUG - 2021		
FIRE FIGHTING DRAWING		



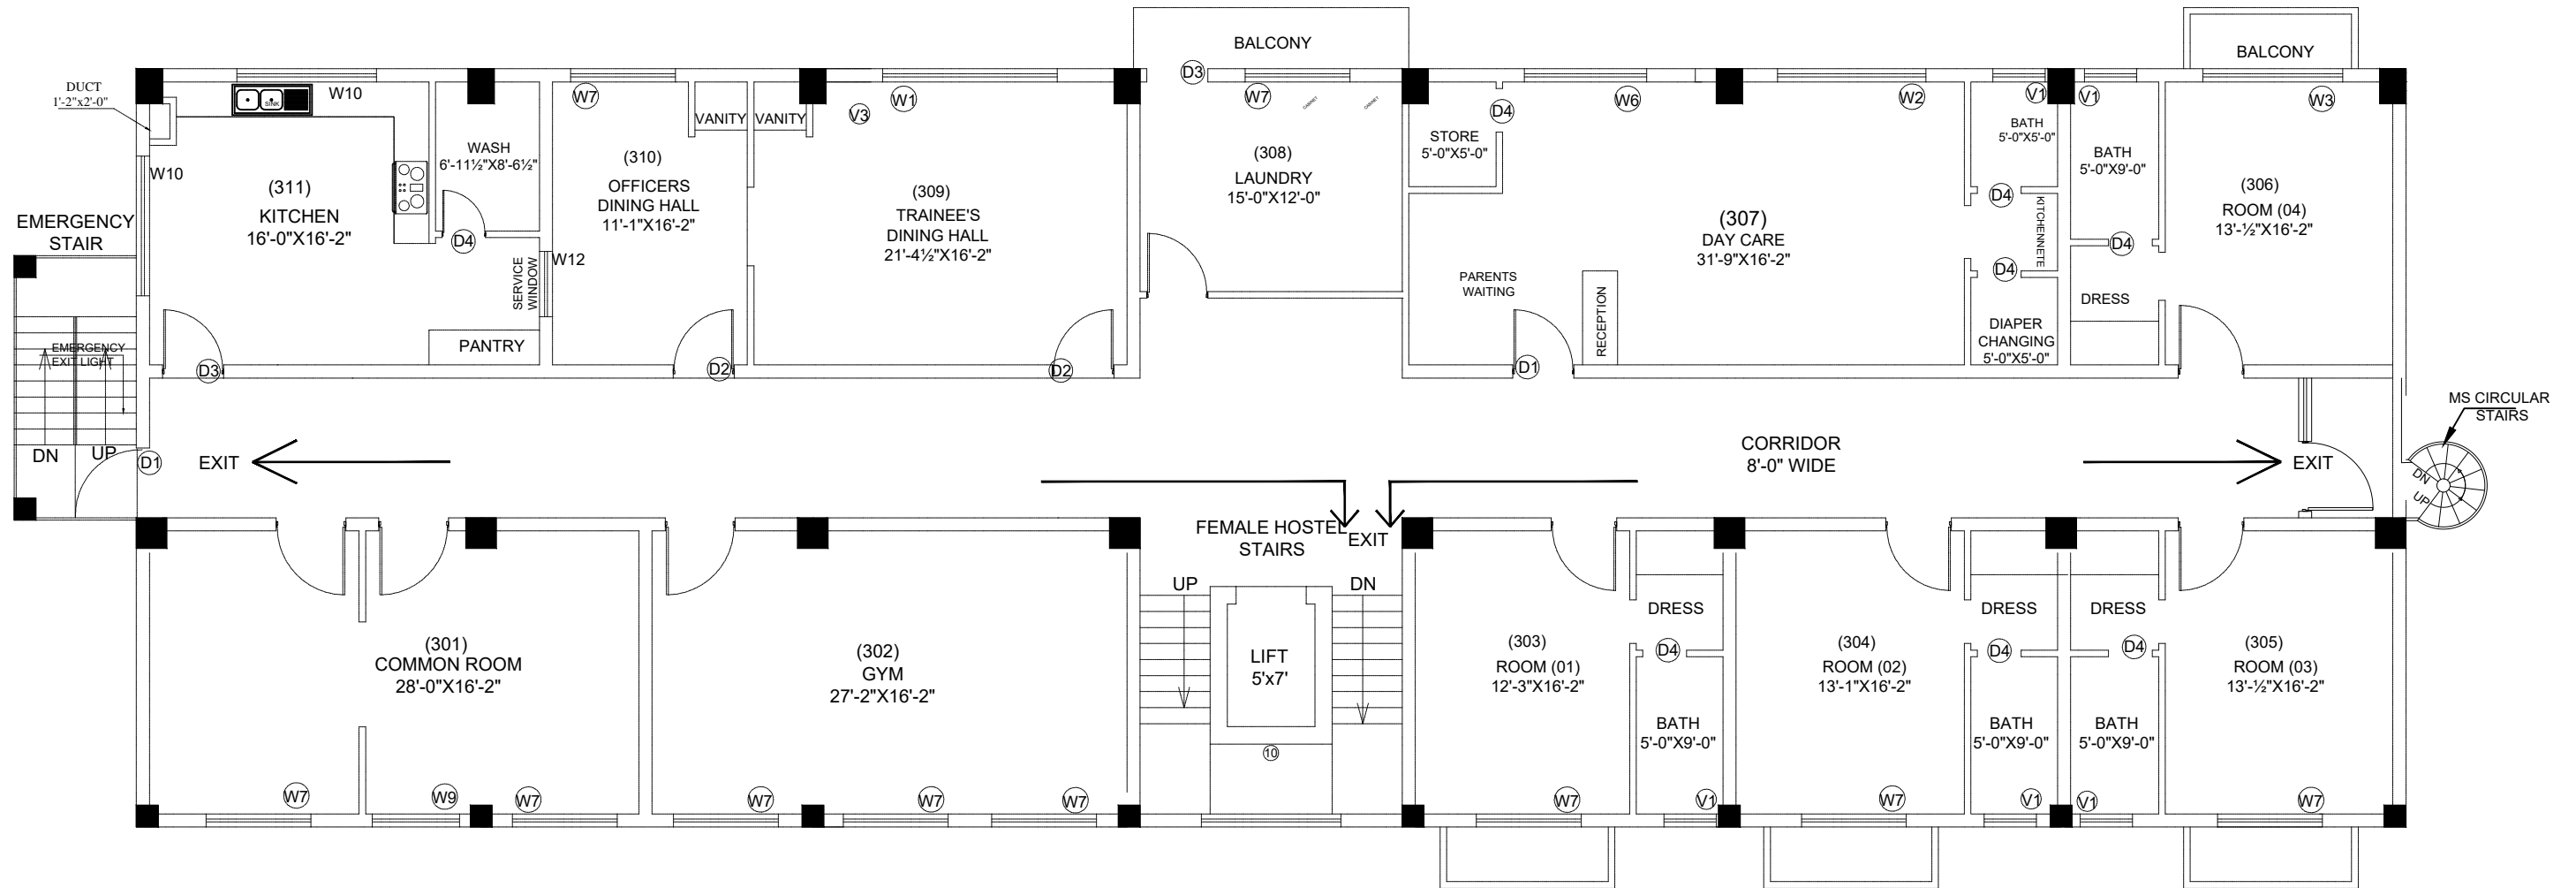

2ND FLOOR PLAN

<i>Project</i>	<i>Client</i>	<i>Consultant</i>	<table><tr><td>SCALE :</td><td>ARCHITECT :</td><td>ASAD HASSAN</td></tr><tr><td>N.T.S</td><td></td><td></td></tr><tr><td>SHEET NO:</td><td>PREPARED BY :</td><td>GHANI REHMAN</td></tr><tr><td>LS - 04</td><td></td><td></td></tr><tr><td>DATE :</td><td>DRAWING TITLE:</td><td>2ND FLOOR LIFE SAFETY PLAN</td></tr><tr><td>AUG - 2021</td><td></td><td></td></tr><tr><td colspan="3">FIRE FIGHTING DRAWING</td></tr></table>	SCALE :	ARCHITECT :	ASAD HASSAN	N.T.S			SHEET NO:	PREPARED BY :	GHANI REHMAN	LS - 04			DATE :	DRAWING TITLE:	2ND FLOOR LIFE SAFETY PLAN	AUG - 2021			FIRE FIGHTING DRAWING			
SCALE :	ARCHITECT :	ASAD HASSAN																							
N.T.S																									
SHEET NO:	PREPARED BY :	GHANI REHMAN																							
LS - 04																									
DATE :	DRAWING TITLE:	2ND FLOOR LIFE SAFETY PLAN																							
AUG - 2021																									
FIRE FIGHTING DRAWING																									
ANTI-NARCOTIC FORCE ACADEMY EXTENSION AND WOMEN'S HOSTEL	UNITED NATIONS DEVELOPMENT PROGRAMME <i>Funding Agency</i> INTERNATIONAL NARCOTICS AND LAW ENFORCEMENT AFFAIRS (INL)	 GSK ENGINEERZ PLANNING - TESTING - DESIGNING & DEVELOPMENT FLAT NO.205 & 206 2nd Floor, Afzal Tower Phase 3, Main Intersection, Peshawar Ph: +92-333-912-6118, +92-334-843-5340 E.mail: gsk.engineerz@gmail.com																							



Project

ANTI-NARCOTIC FORCE ACADEMY
EXTENSION AND WOMEN'S HOSTEL


Client

UNITED NATIONS DEVELOPMENT PROGRAMME

Funding Agency

INTERNATIONAL NARCOTICS AND LAW
ENFORCEMENT AFFAIRS (INL)

Consultant

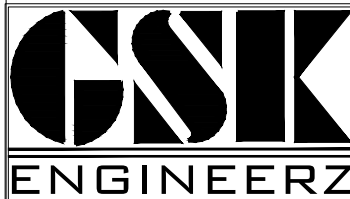

GSK ENGINEERZ

PLANNING - TESTING - DESIGNING & DEVELOPMENT
FLAT NO.205 & 206 2nd Floor, Afzal Tower Phase 3,
Main Intersection, Peshawar
Ph: +92-333-912-6118, +92-334-843-5340
E-mail: gsk.engineerz@gmail.com

SCALE :	N.T.S	ARCHITECT :	ASAD HASSAN
SHEET NO :	LS - 05	PREPARED BY :	GHANI REHMAN
DATE :	AUG - 2021	DRAWING TITLE :	3RD FLOOR LIFE SAFETY PLAN
FIRE FIGHTING DRAWING			

