


PREVIOUS APPROVAL NO.			
PROJECT			
UNDP 7th floor interior			
LOCATION OF THE PROJECT			
IDB BHABAN, AGARGAON			
NAME & SIGNATURE OF THE OWNER			
UNDP			
SHEET TITLE			
CLINIC LAYOUT			
ARCHITECT			
TALHA MAHMUD DIPTA			
MEMBERSHIP / REGISTRATION NO. D-021			
PROJECT ARCHITECT			
MR. SAJJAD HASAN SULTAN			
MEMBERSHIP / REGISTRATION NO. D-021			
SIGNATURE OF THE STRUCTURAL ENGINEER			
SIGNATURE OF THE ARCHITECT			
TALHA MAHMUD DIPTA			
MEMBERSHIP / REGISTRATION NO. D-021			
HOUSE NO. 44, BLOCK B, ROAD 02, NIKETON			
DUBLIN 4, IRELAND			
SCALE	SHEET NO.	FORMAT	DATE
AS SHOWN		A3 SIZE	05.11.2016

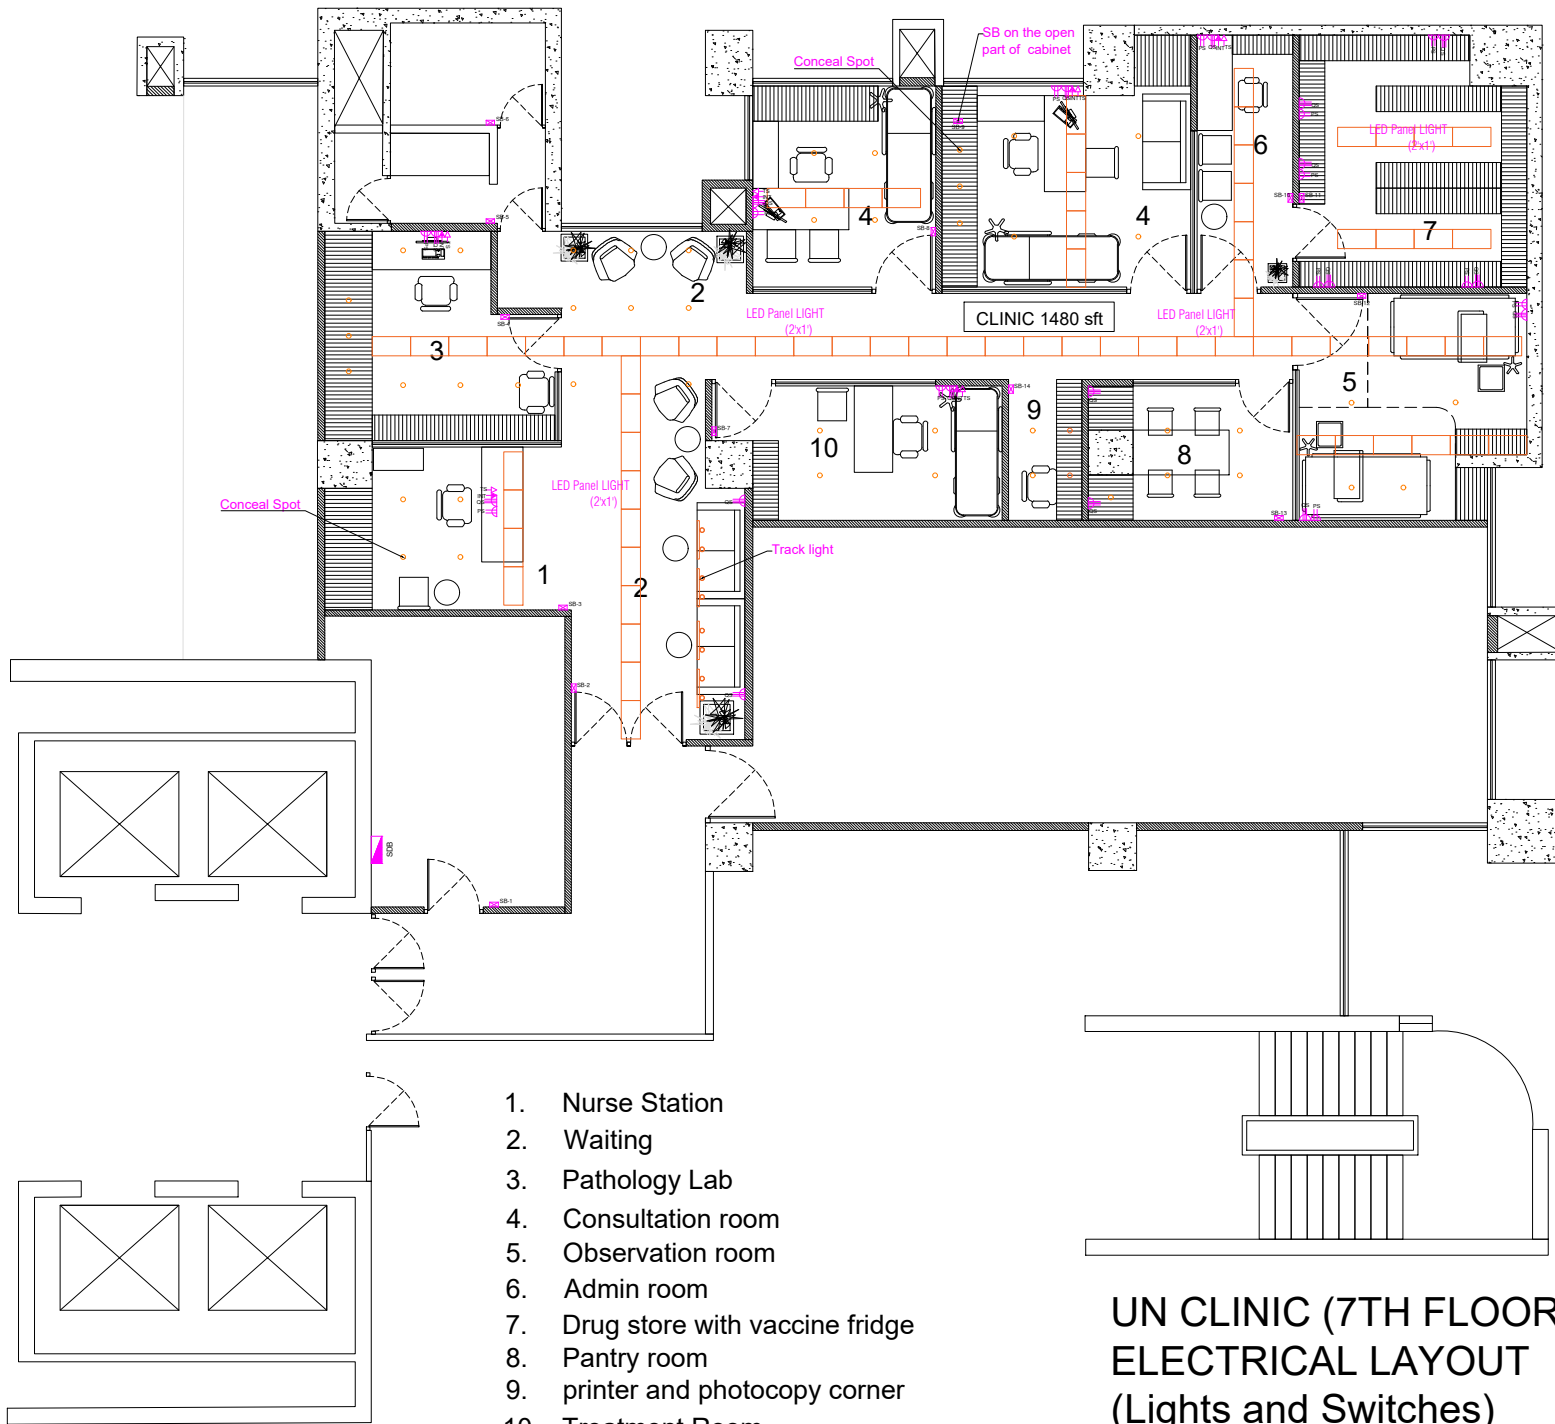

UN CLINIC (7TH FLOOR)
ELECTRICAL LAYOUT
(Lights and Switches)

1. Nurse Station
2. Waiting
3. Pathology Lab
4. Consultation room
5. Observation room
6. Admin room
7. Drug store with vaccine fridge
8. Pantry room
9. printer and photocopy corner
10. Treatment Room

