




Room Schedule			
Department	Name	Perimeter	Area
CIRCULATION	CORRIDOR	25526	38 m²
CIRCULATION	CORRIDOR	87737	104 m²
CIRCULATION	CORRIDOR	21960	22 m²
COMMON AREA	CAFE	23033	33 m²
COMMON AREA	CO-WORKING SPACE AND EVENT AREA	67915	224 m²
COMMON AREA	KITCHEN	19951	25 m²
COMMON AREA	STAFF OFFICE	15114	14 m²
COMMON AREA	UNIPOD MANAGER OFFICE	20500	23 m²
DESIGN LAB	DESIGN LAB	42920	97 m²
MAKERSPACE	AR/VR AUDIOGRAHPY AND VIDEOGRAPHY STUDIO	35610	79 m²
MAKERSPACE	DARKROOM	14862	14 m²
MAKERSPACE	ELECTRONICS	39690	76 m²
MAKERSPACE	FOOD / AGRO TECH	27513	47 m²
MAKERSPACE	GREEN TECH	28697	51 m²
MAKERSPACE	MECHANICAL WORKSHOP	40486	88 m²
MAKERSPACE	RAPID PROTOTYPING	43277	115 m²
MAKERSPACE	TEXTILE	37850	64 m²
MAKERSPACE	WOOD WORKSHOP	34480	69 m²
Grand total: 18			1182 m²

Department Legend

- CIRCULATION
- COMMON AREA
- DESIGN LAB
- MAKERSPACE

1 Ground Floor Plan Complete
1 : 100

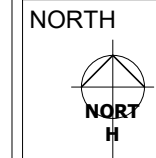

Notes:

No. Date Issued

Prints Issued

Rev. Date Description

Rev. No.

Project

<Project Address>

Drawing Title

FLOOR PLANS

Drg. No. A102


13/10/2022 1 : 100
Date Scale

Client


<Address>
<Contact No.>

Architect
<Firm Name>
<Address>
<Contact No.>

13/10/2022 11:15:17 am

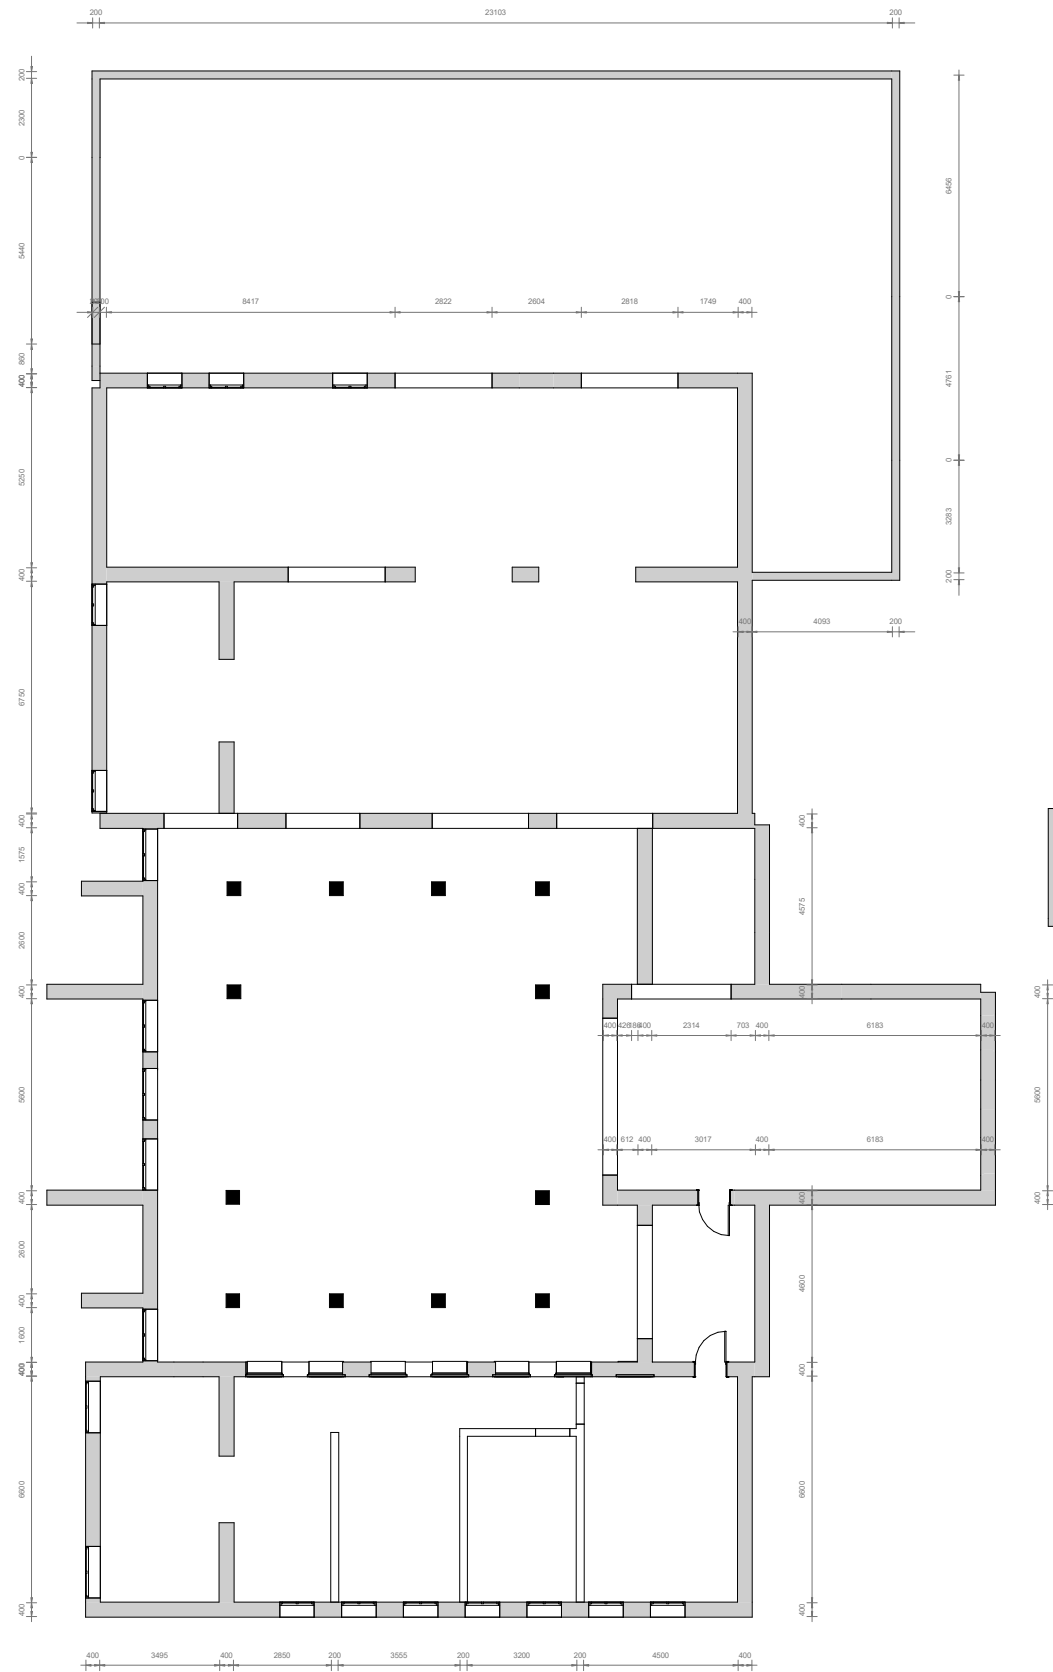

1 Ground Floor Plan Existing
1 : 100

 

Notes:

No.	Date	Issued
-----	------	--------

Prints Issued

Rev.	Date	Description
------	------	-------------

Rev. No.

Project

<Project Address>

Drawing Title

FLOOR PLANS


Drg. No.	A103
----------	------

05/11/19	1 : 100
Date	Scale

Client


<Address>
<Contact No.>

Architect
<Firm Name>
<Address>
<Contact No.>

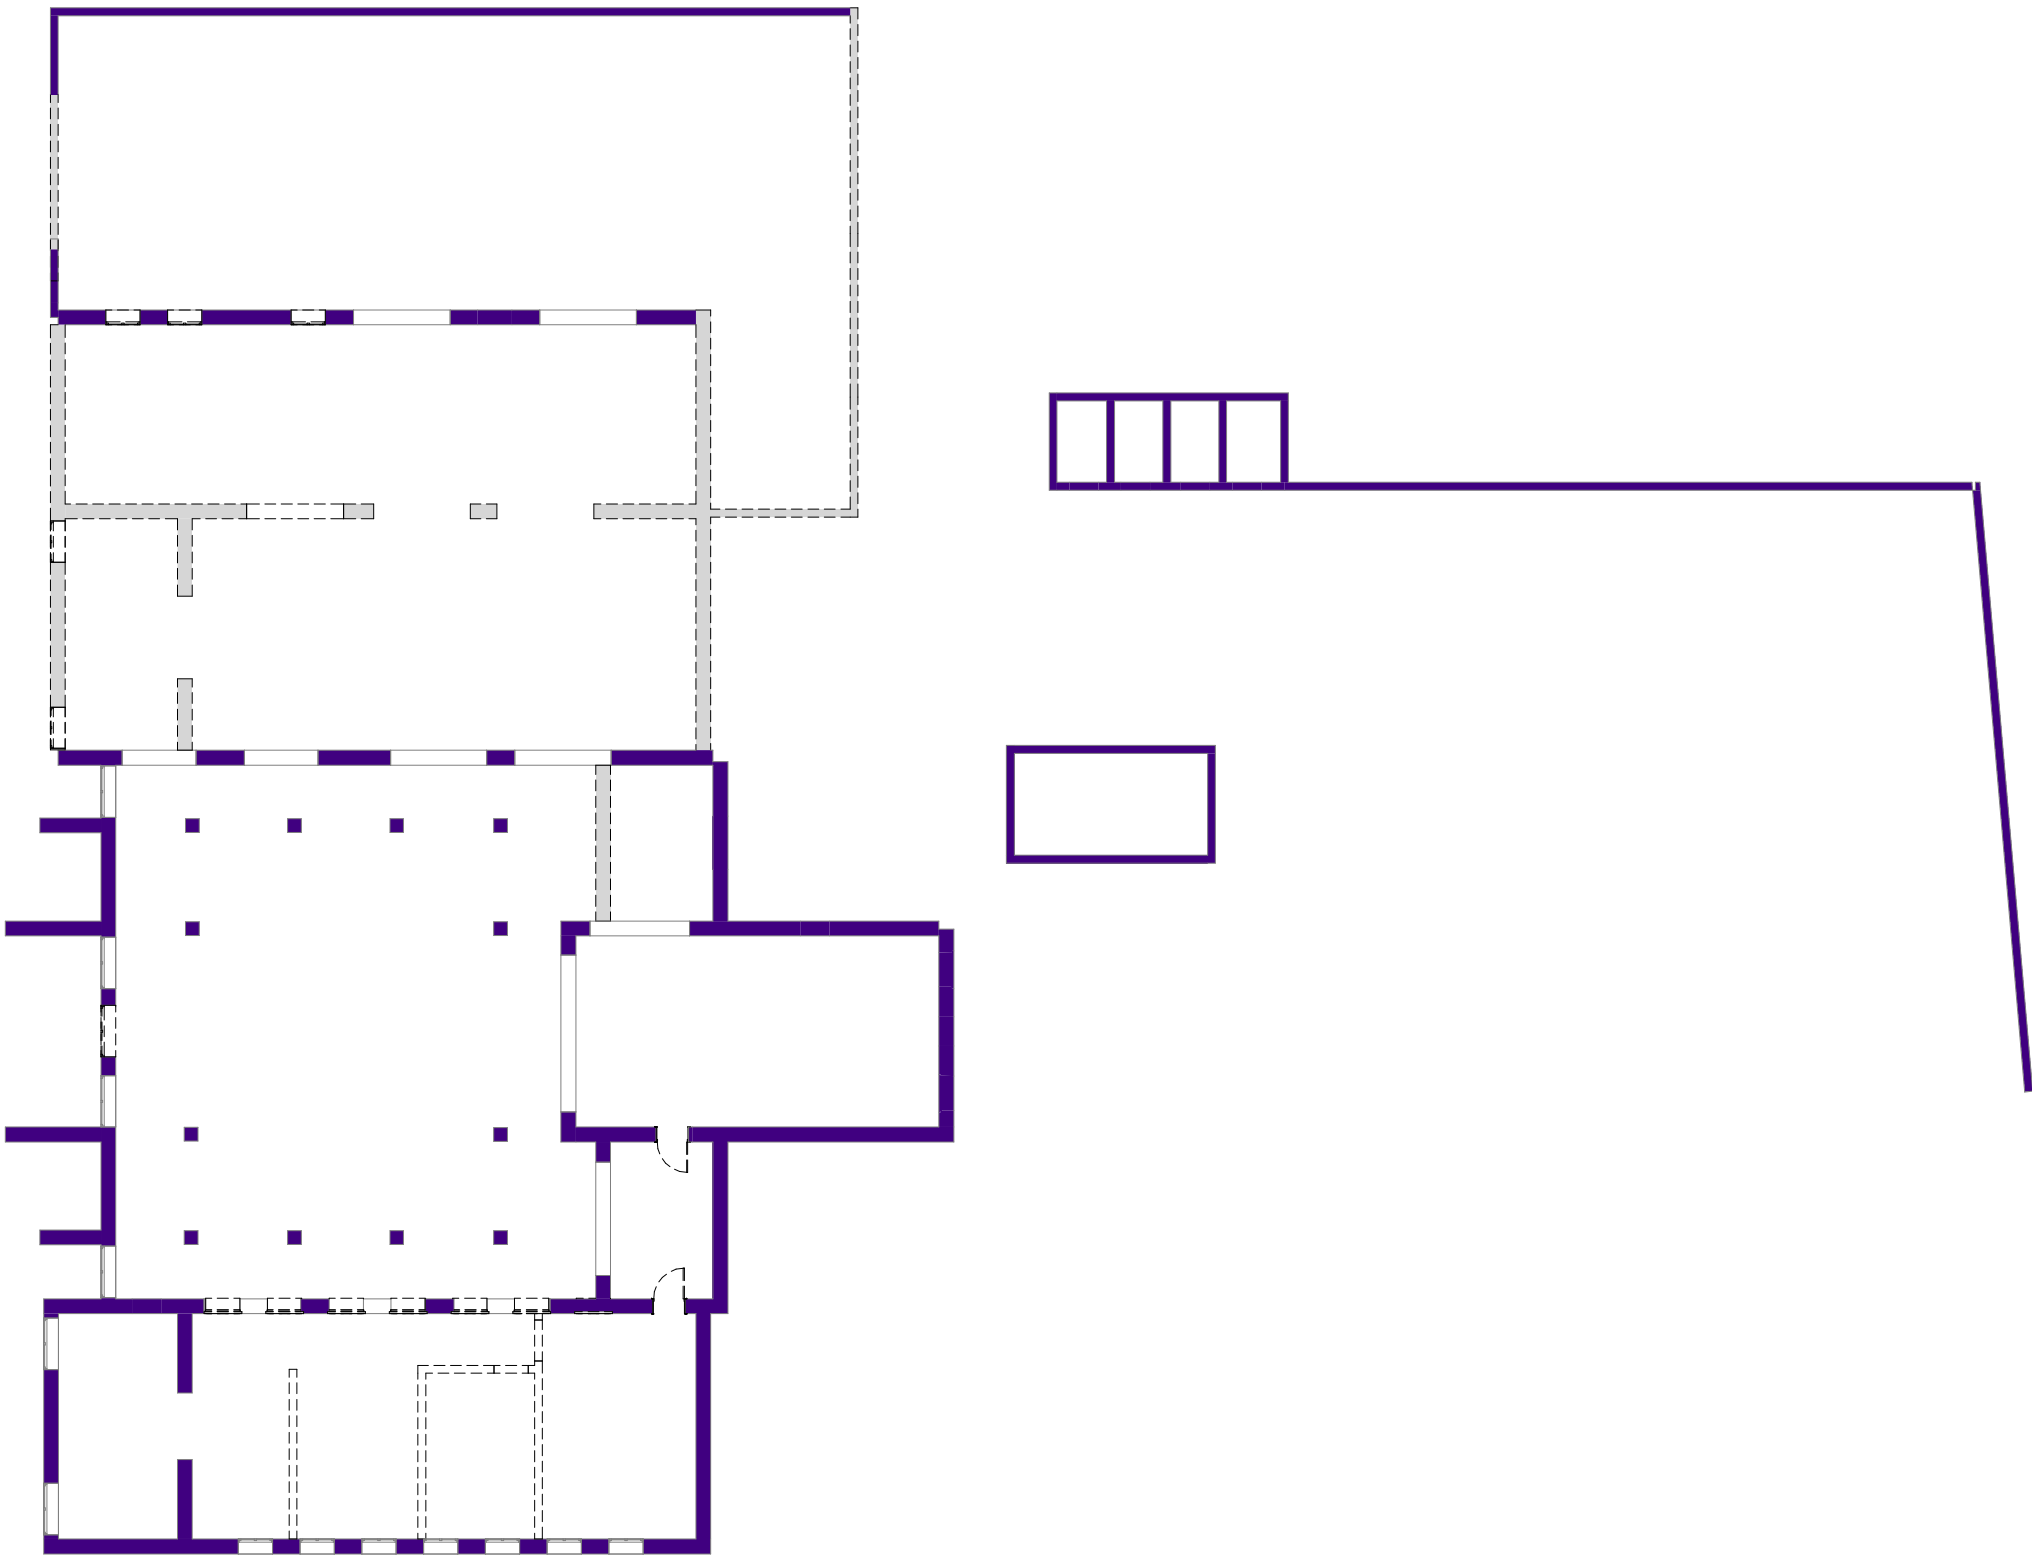

1 Ground Floor Plan Demo
1 : 100

NORTH		
Notes:		
No.	Date	Issued
Prints Issued		
Rev.	Date	Description
Rev. No.		
Project		
<Project Address>		
Drawing Title		
FLOOR PLANS		
Drg. No.	A104	
06/02/22	1 : 100	
Date	Scale	
Client		
<Address> <Contact No.>		
Architect		
<Firm Name> <Address> <Contact No.>		

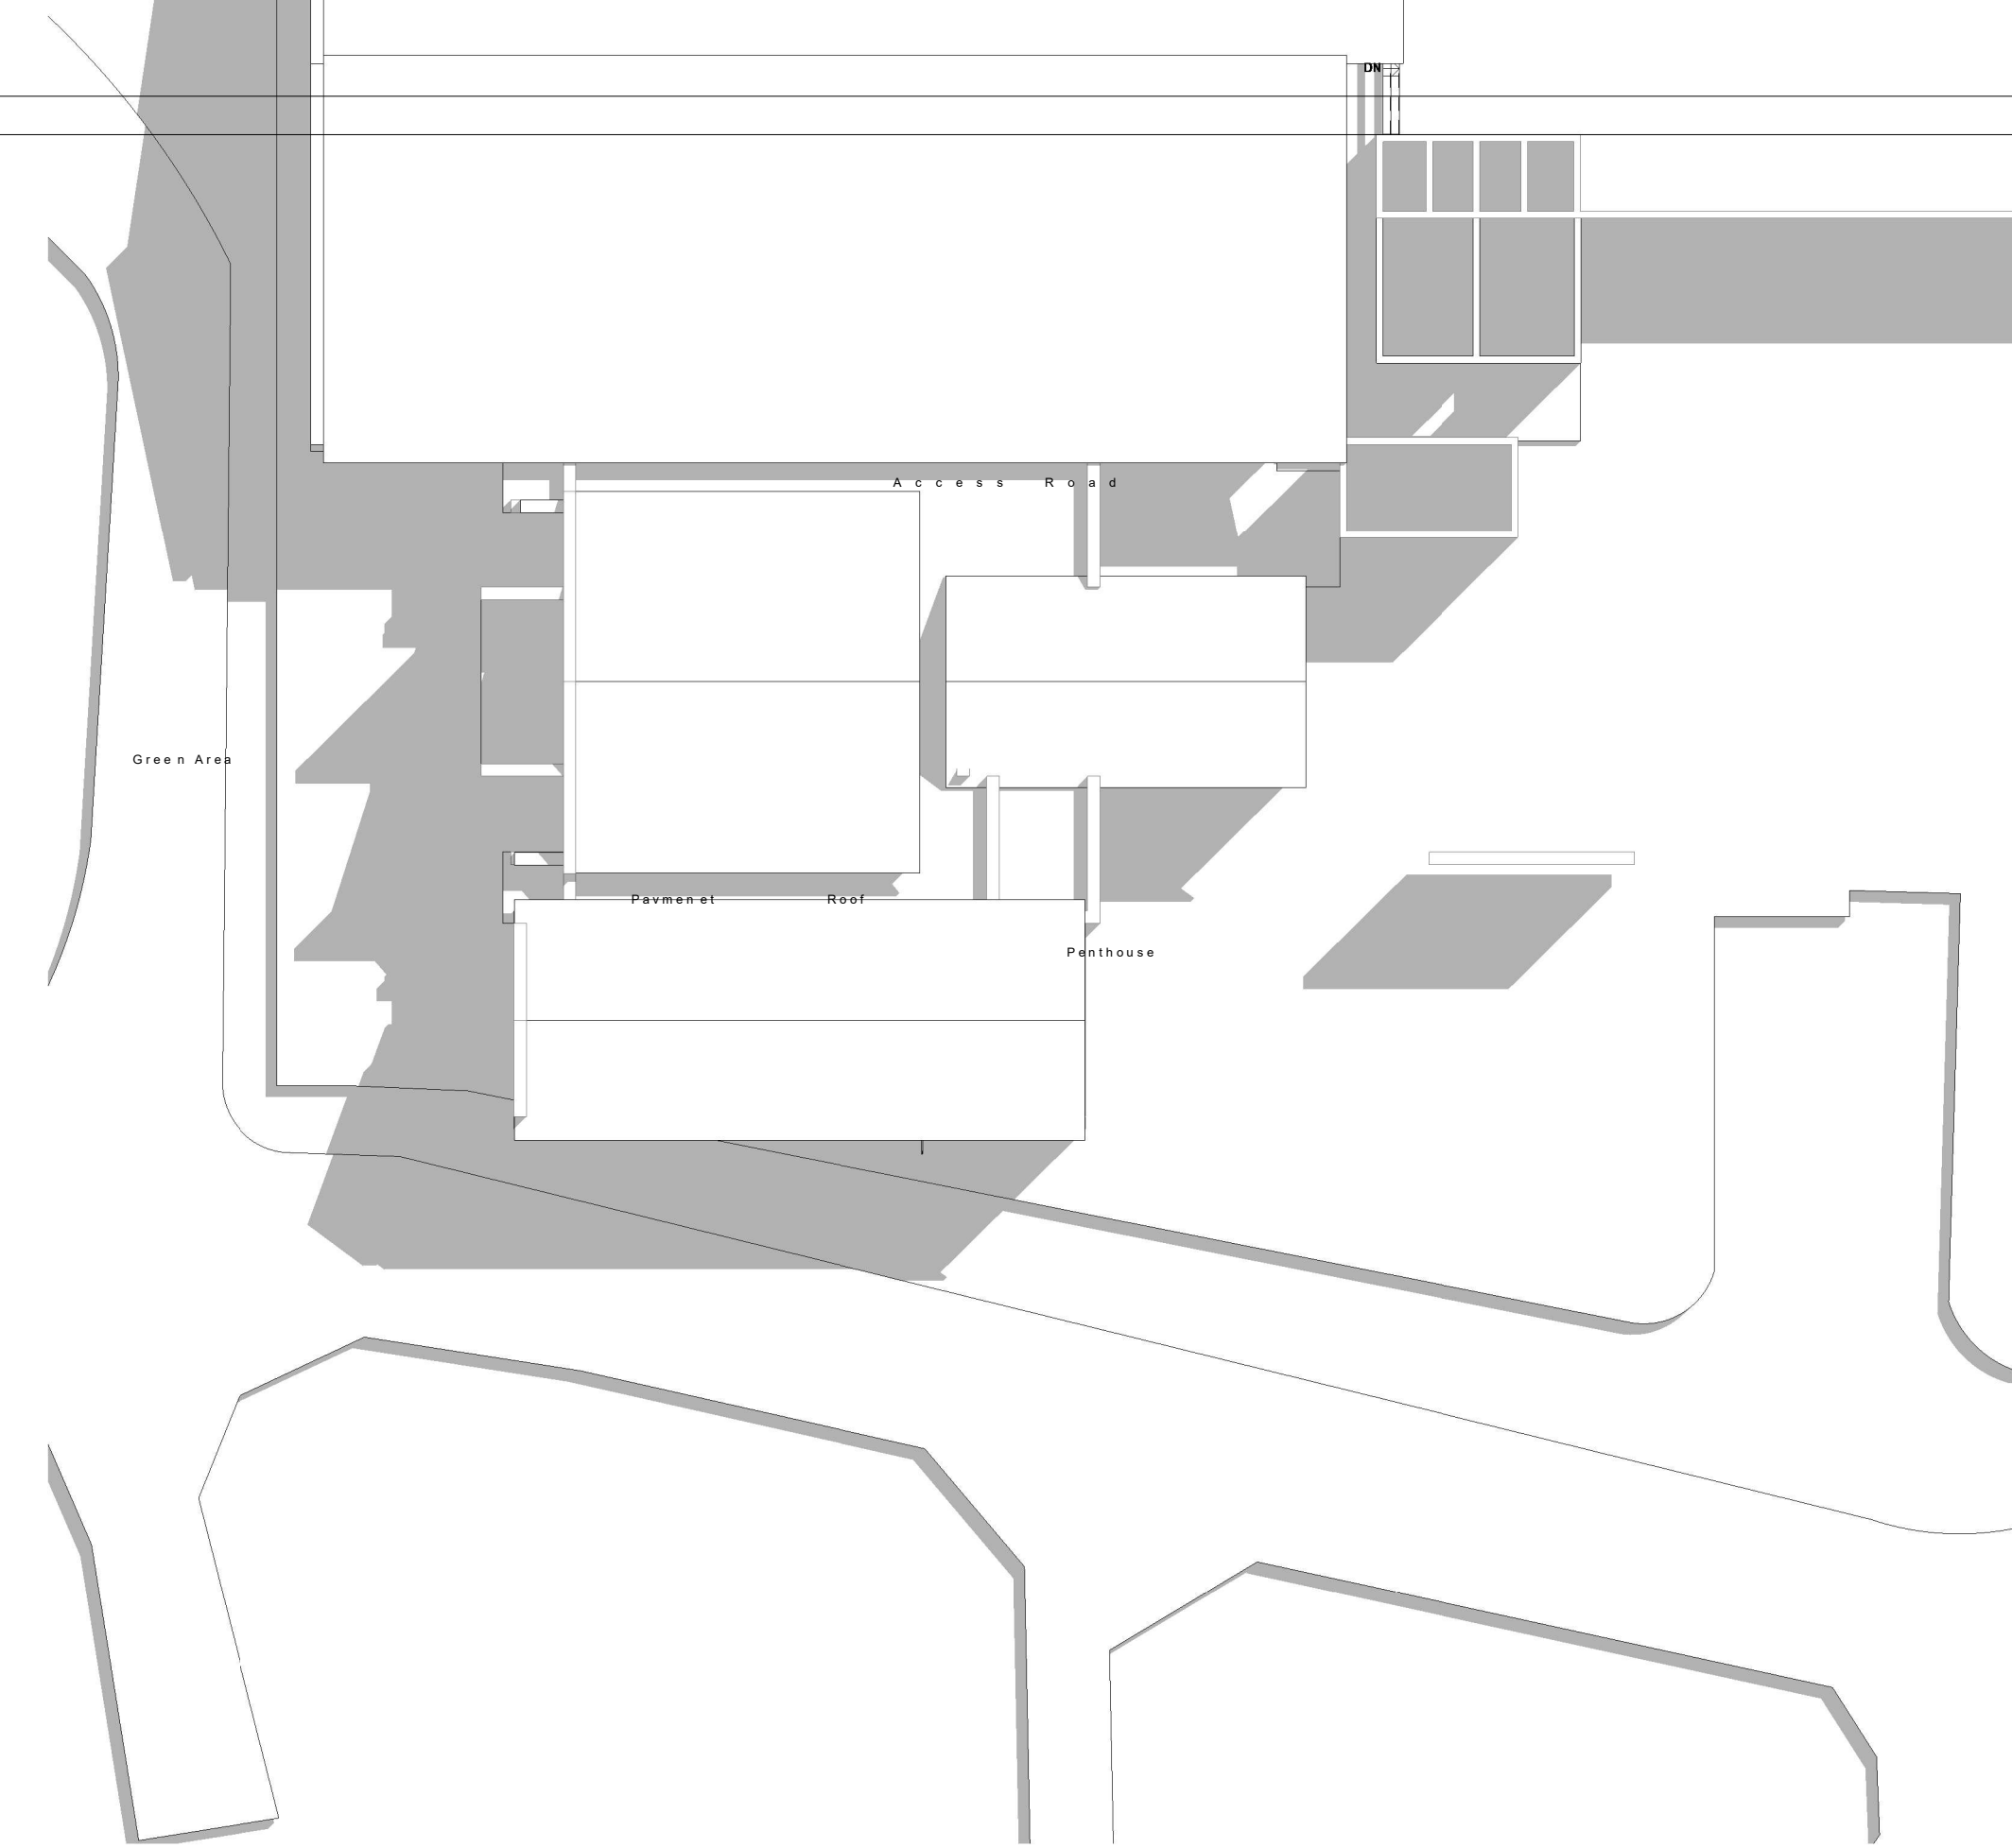


Notes:

Rev No.	Date	Description
Revision No.		
Architect Stephen Dominic		
<Address> <Contact No.>		
Client Name		
Location Plot No: 71, Block 4I, Lologo		
Drg. Title SITE PLAN		
Date	14/07/2022	
Scale	1 : 200	
Drg. No.		
A101		

1


Site Plan

1 : 200

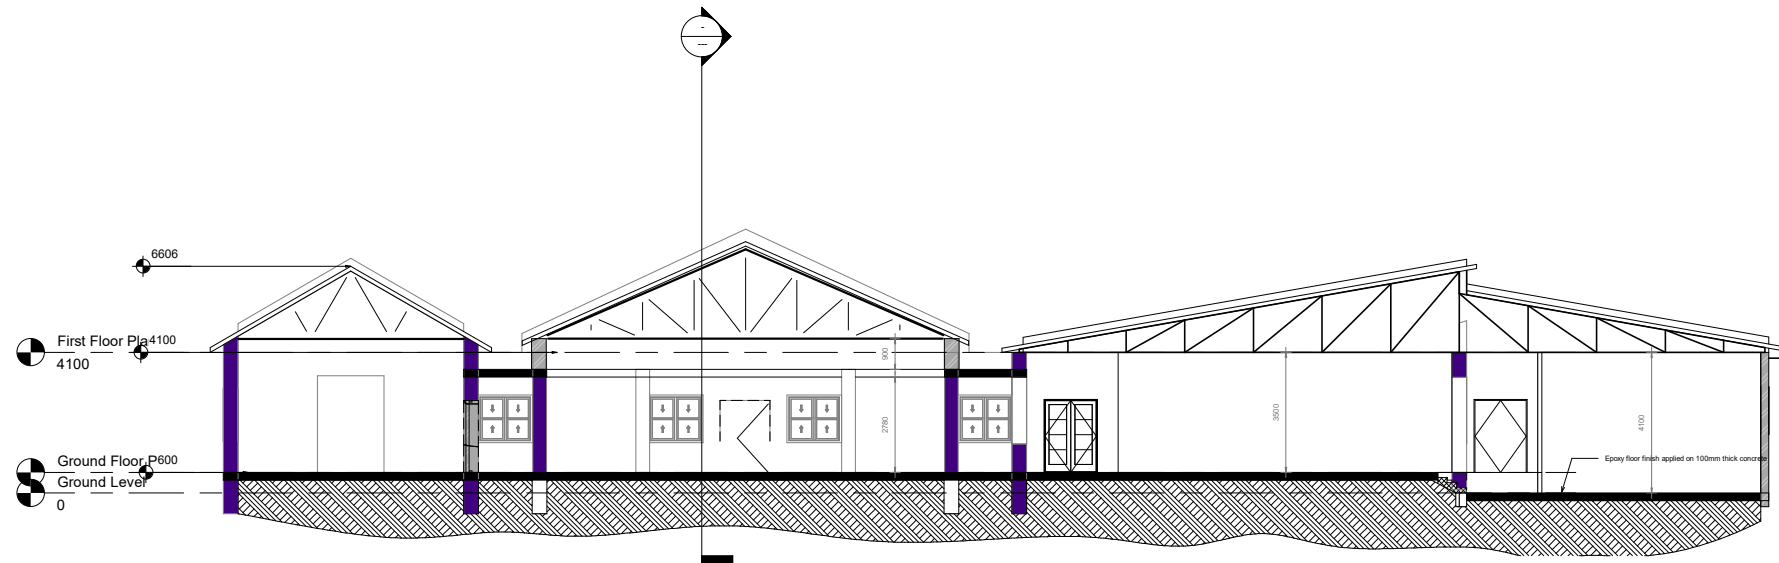


1 Section 3
1 : 100


NORTH	
Notes:	
No.	Date Issued
Prints Issued	
Rev.	Date Description
Rev. No.	
Project	
<Project Address>	
Drawing Title	
SECTIONS	
Drg. No.	A201
05/16/19	1 : 100
Date	Scale
Client	
<Address> <Contact No.>	
Architect <Firm Name> <Address> <Contact No.>	

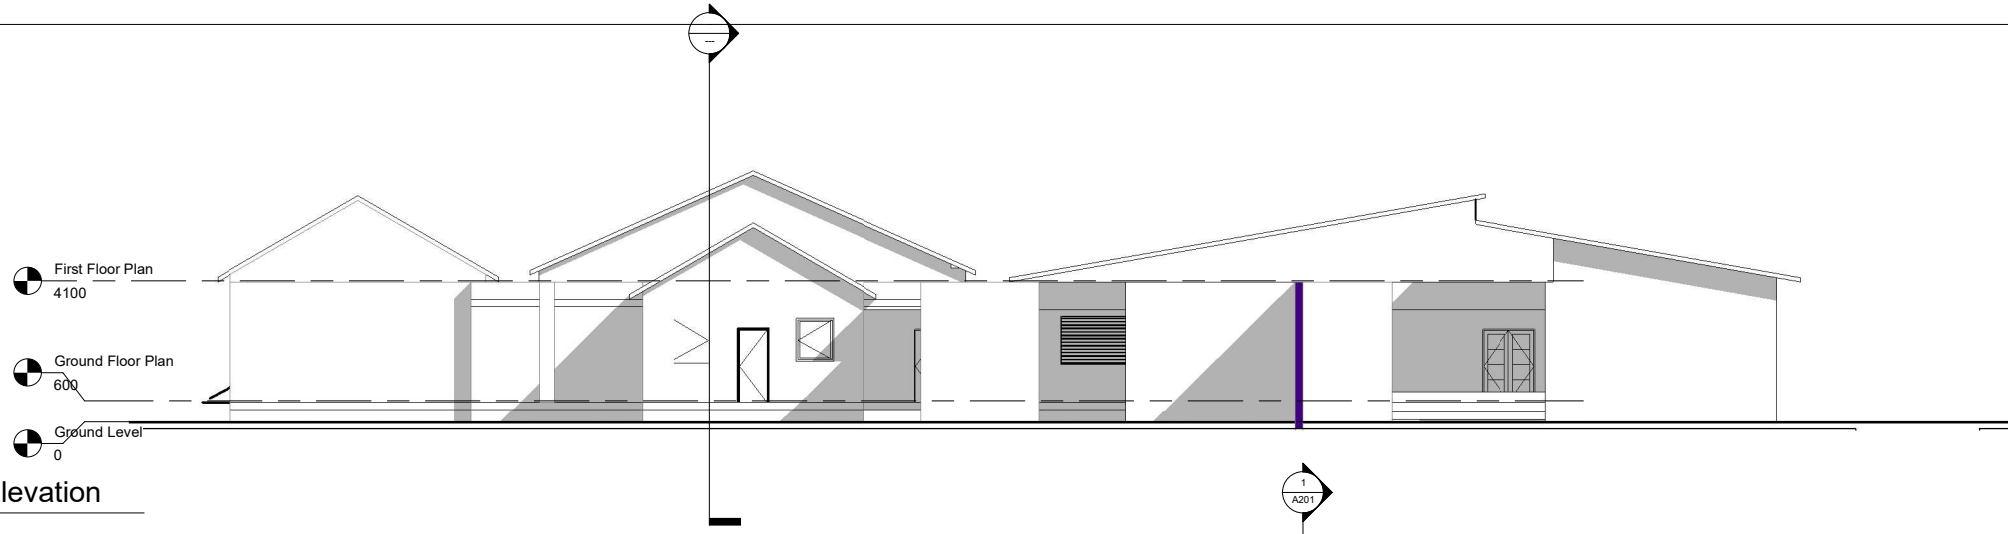


1 East Elevation
1 : 100

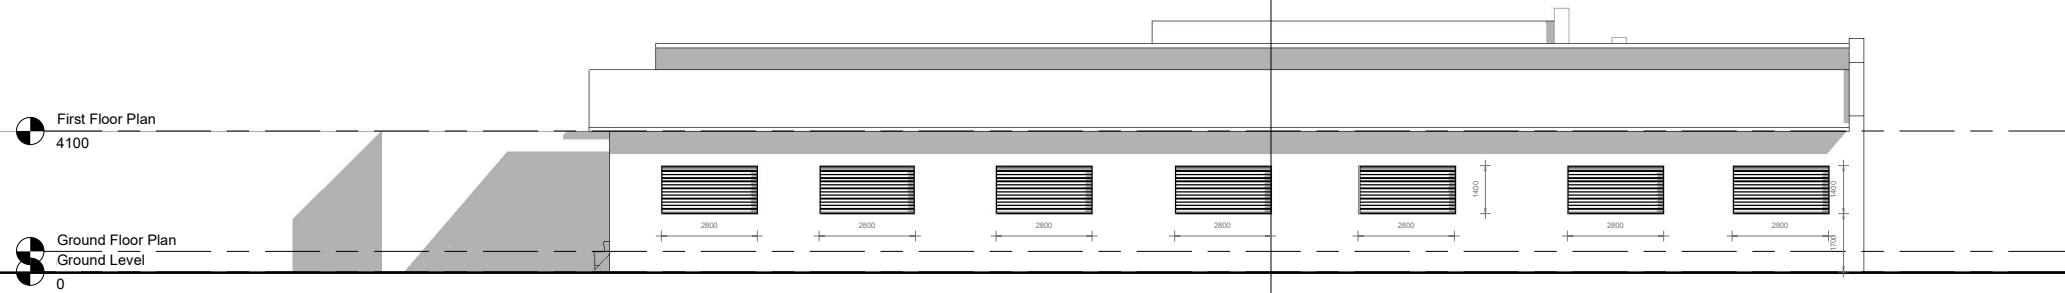

2 North Elevation
1 : 100

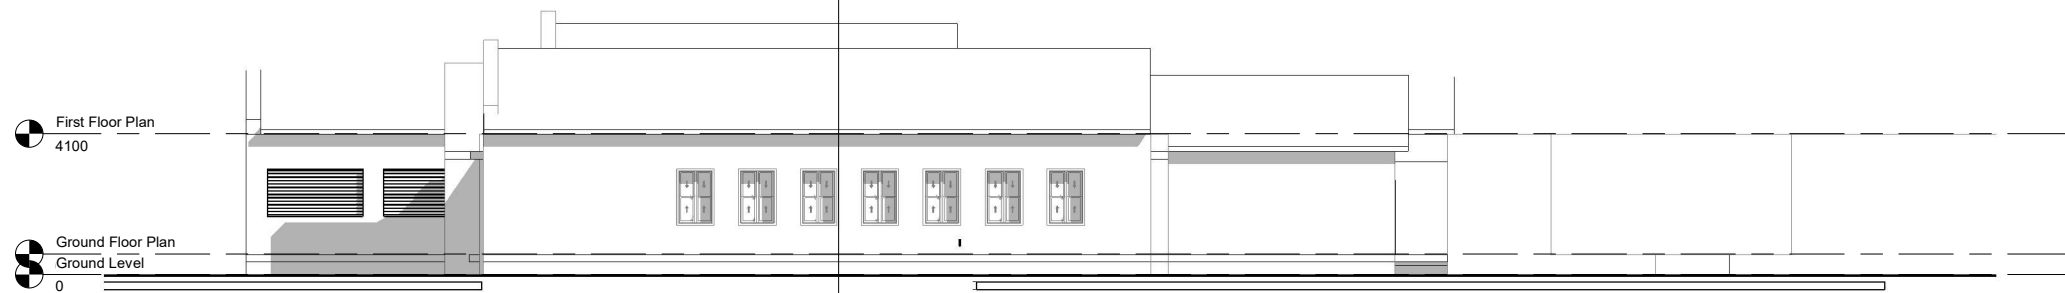

3 South Elevation1
1 : 100

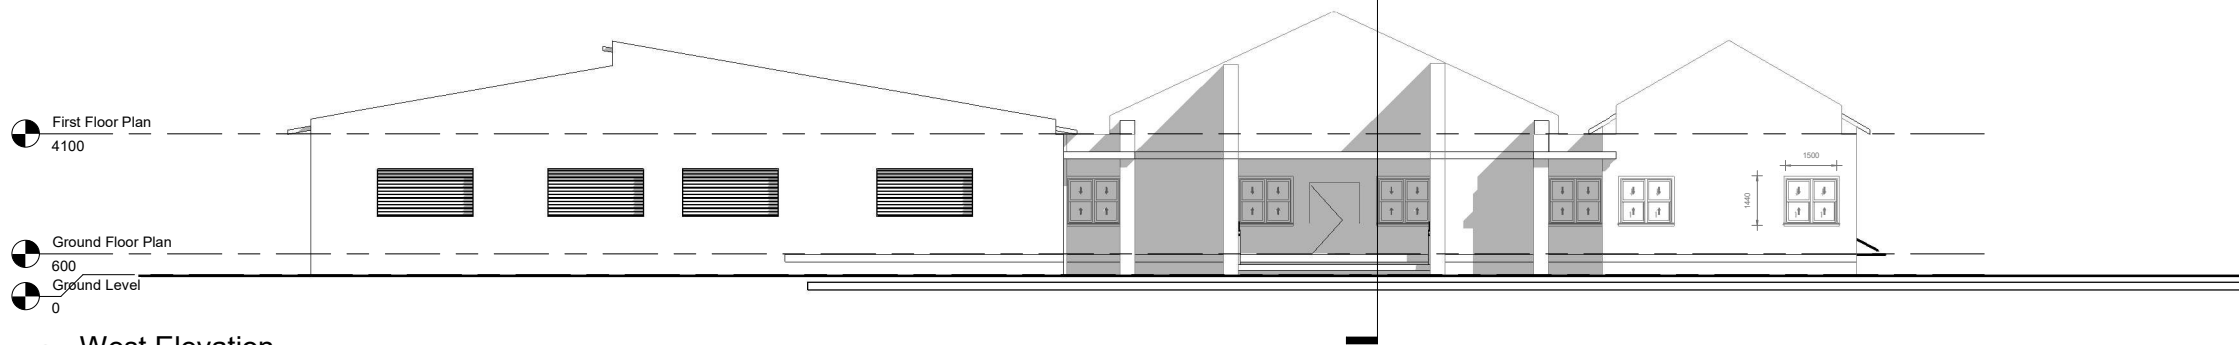

4 West Elevation
1 : 100


NORTH	
Notes:	
No.	Date Issued
Prints Issued	
Rev.	Date Description
Rev. No.	
Project	
<Project Address>	
Drawing Title	
ELEVATIONS	
Drg. No.	A301
05/16/19	1 : 100
Date	Scale
Client	
<Address> <Contact No.>	
Architect <Firm Name> <Address> <Contact No.>	



Lighting Fixture Schedule		
Type Mark	Family and Type	Count
L01	MADERA_3_LED: 497537 MADERA 3 LED LED 620X620MM 5200LM 840 IP44 PRM WHITE(41W)	70
L02	Lighting_Ceiling-Mounted_RZB_Flat-Slim: Round LED Ceiling light	22

1 Ground Floor Lighting Plan
1 : 100

NORTH	
Notes:	
No.	Date Issued
Prints Issued	
Rev.	Date Description
Rev. No.	
Project	
<Project Address>	
Drawing Title	
LIGHTING CEILING PLAN	
Drg. No.	E106
07/13/22	1 : 100
Date	Scale
Client	
<Address> <Contact No.>	
Architect <Firm Name> <Address> <Contact No.>	

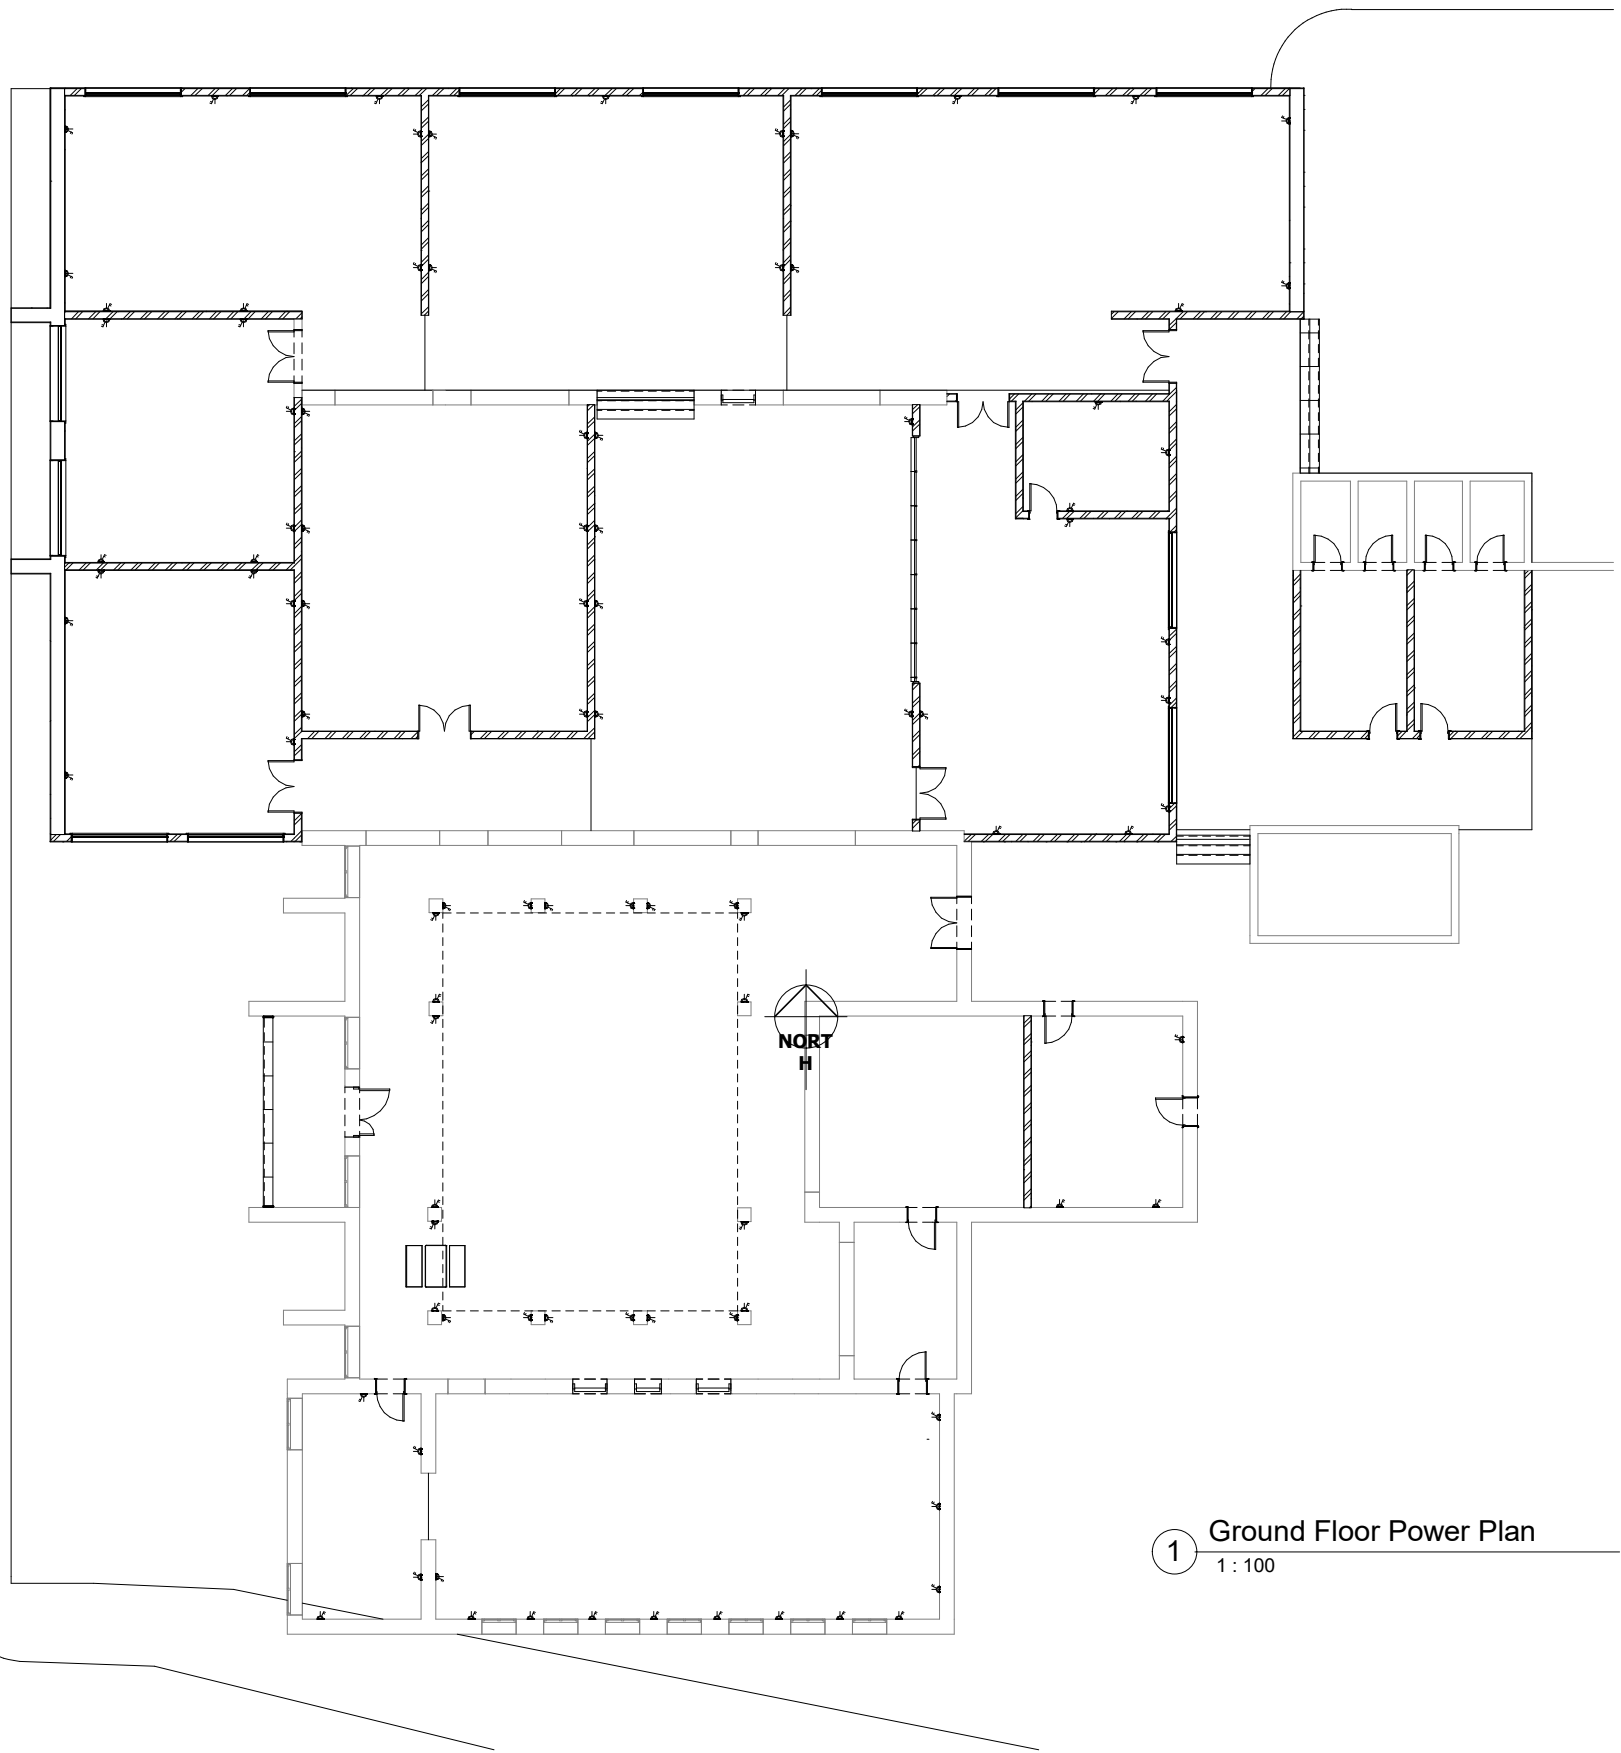

1 Ground Floor Power Plan
1 : 100

NORTH	
Notes:	
No.	Date Issued
Prints Issued	
Rev.	Date Description
Rev. No.	
Project	
<Project Address>	
Drawing Title	
POWER FLOOR PLAN	
Drg. No.	E101
Date	1 : 100 Scale
Client	
<Address> <Contact No.>	
Architect <Firm Name> <Address> <Contact No.>	